


ONTARIO, CA 91764




100% SUBMITTAL

C-1	COVER SHEET DRAWING INDEX
SL	SYMBOLS LEGEND
AB-1	FLOOR PLAN LEVEL 1
AB-2	FLOOR PLAN LEVEL 2
AB-3	EXTERIOR ELEVATIONS
AB-4	EXTERIOR ELEVATIONS
AB-5	ROOF PLAN
AB-6	SECTIONS
AB-7	SITE PLAN

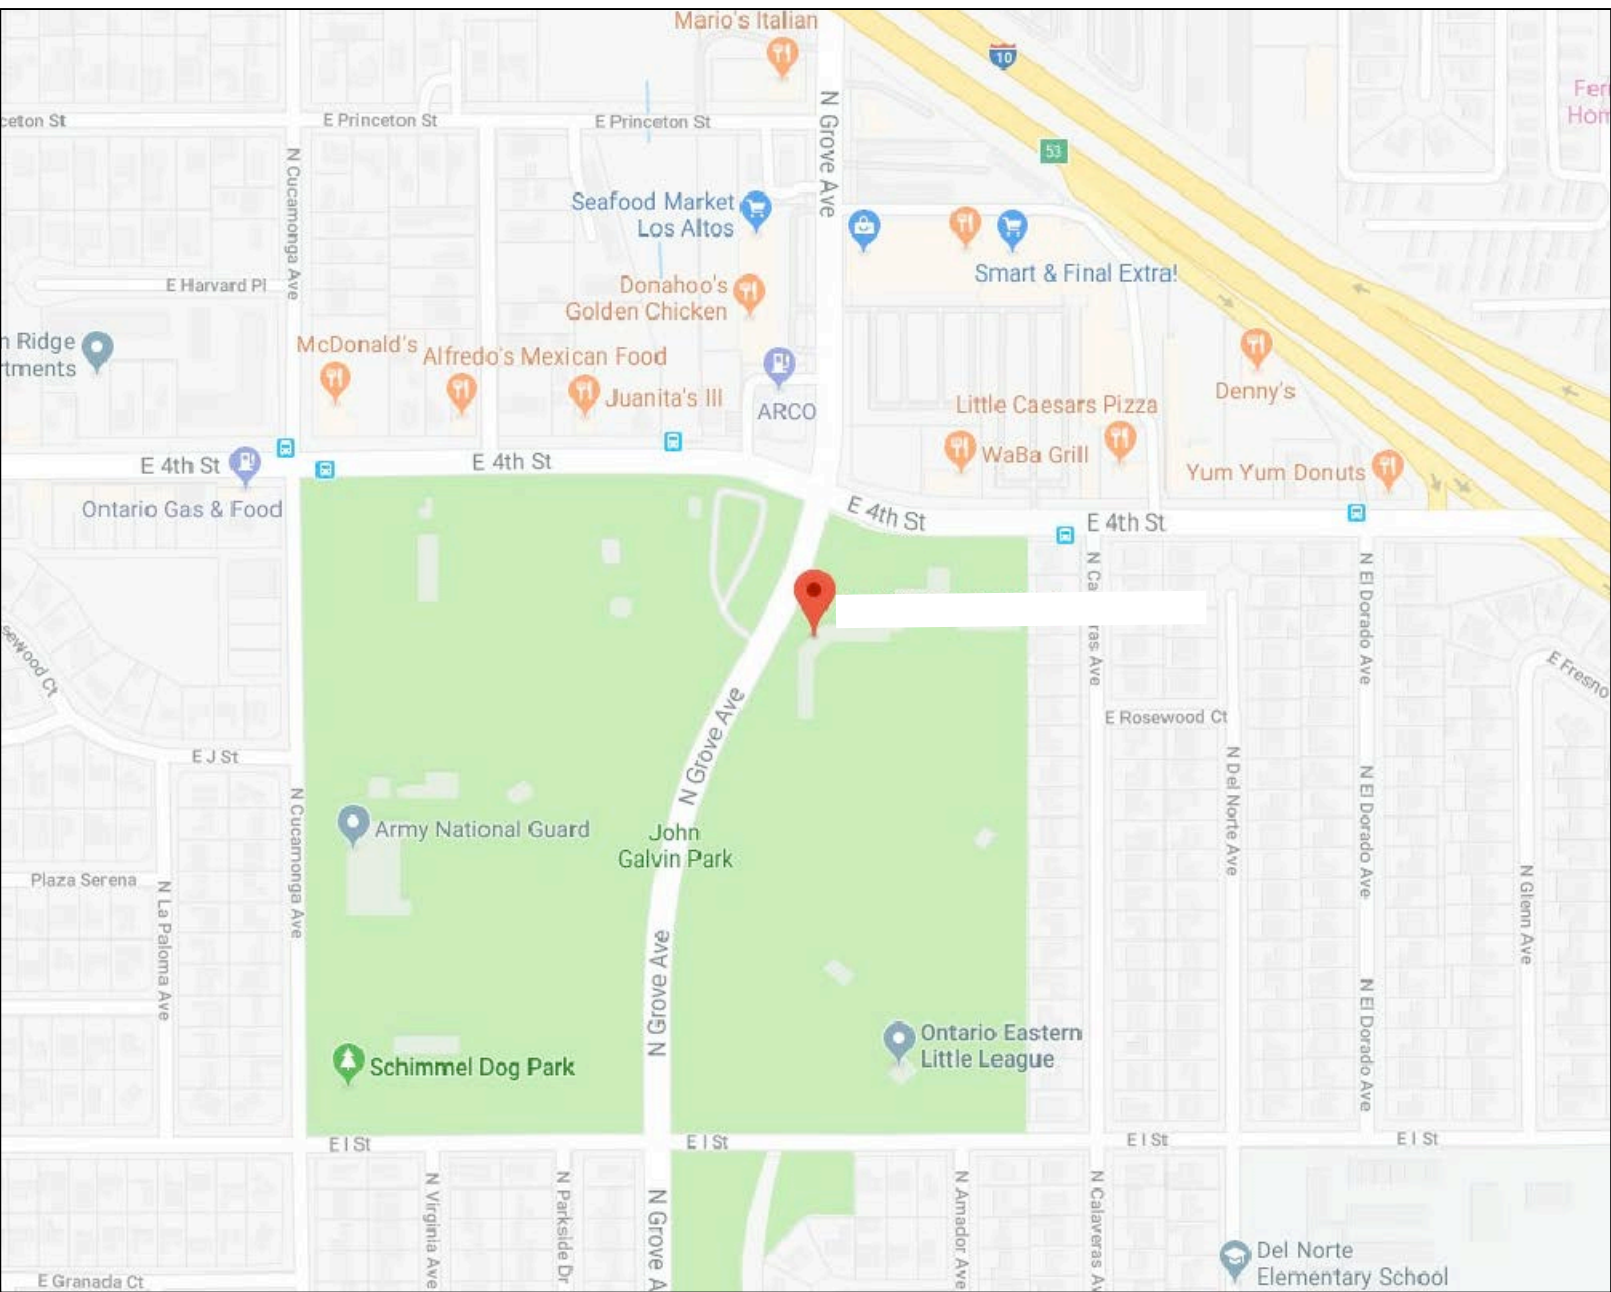


 VICINITY MAP
NTS

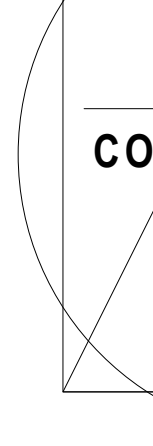

AS BUILT
PROFESSIONALS

www.asbuiltprofessionals.com

 A DIVISION OF:



AEC
CONSULTANTS INC

844.272.8458
844 AS BUILT

© 2018 AEC CONSULTANTS INC

ARCHITECTURAL AS BUILT

Jay Littleton Ballpark

ONTARIO, CA 91764

Q1	100% SUBMISSION	SEE COVER SHEET
N0.	ISSUES REVISIONS	DATE
		SHEET TITLE
COVER SHEET		
HL	PROJECT MANAGER	
HL	PROJECT DIRECTOR	
012317-1	PROJECT NUMBER	
	SCALE	
CL	DRAWN BY	
	SHEET NUMBER	

C-1

SYMBOLS LEGEND

RCP

	EXHAUST VENT		TRACK LIGHT OR VANITY LIGHT
	CEILING MOUNTED LIGHT FIXTURE		WALL-MOUNTED LIGHT FIXTURE
	CEILING MOUNTED DIRECTIONAL LIGHT		EMERGENCY EXIT SIGN
	RECESSED CAN LIGHT		EMERGENCY EXIT LIGHT
	EYEBALL OR SMALL CAN LIGHT		EMERGENCY EXIT LIGHT W/ SIGN
	PENDANT LIGHT		LIGHTED STAIR SIGN
	INDIVIDUAL FLUOR. LAY-IN FIXTURE 4 BULB		FLOOD LIGHT
	INDIVIDUAL FLUOR. HANGING FIXTURE 2 BULB		PHOTO CELL
	INDIVIDUAL FLUOR. FLUSH MOUNT FIXTURE 4 BULB		CEILING FAN
	CAMERA		CEILING FAN W/ LIGHT KIT
	MOTION DET.	7-2-6 CEILING HEIGHT AND TRIM 7'-2" ABOVE FLOOR BELOW WITH 6" CROWN MOULDING. NOTE: ALL CEILINGS NOT LABELED ARE PLASTER. CEILINGS SHOWN WITH A GRID ARE LAY IN ACOUSTICAL TILE..	
	SUPPLY VENT		
	SUPPLY VENT		
	RETURN VENT		
	RETURN VENT		
	SPEAKER		JUNCTION BOX

ELECTRIC

	DATA OUTLET
	TELEPHONE JACK
	ELECTRIC SWITCH
	CABLE TELEVISION OUTLET
	DUPLEX RECEPTACLE OUTLET
	SPECIAL PURPOSE CONNECTION OR OUTLET
	QUADRUPLIX RECEPTACLE OUTLET
	FLOOR DUPLEX RECEPTACLE OUTLET
	ELECTRIC PANEL
	ELECTRIC METER
	BUTTON SWITCH
	DISCONNECT SWITCH
	GROUND/FLOOR LIGHT
	KEY PAD

FIRE PROTECTION


	FIRE EXTINGUISHER
	FIRE PULL
	FIRE ALARM (HORN/SRTOBE)
	SMOKE DETECTOR
	SMOKE ALARM SPEAKER
	SPRINKLER HEAD CEILING MOUNT
	SPRINKLER HEAD WALL MOUNT

MEP


	THERMOSTAT
	FLOOR DRAIN
	VALVE
	HOSE BIB
	WATER SUPPLY
	SUSPENDED GAS HEATER

MISC


	BOLLARD
	SPOT ELEVATION

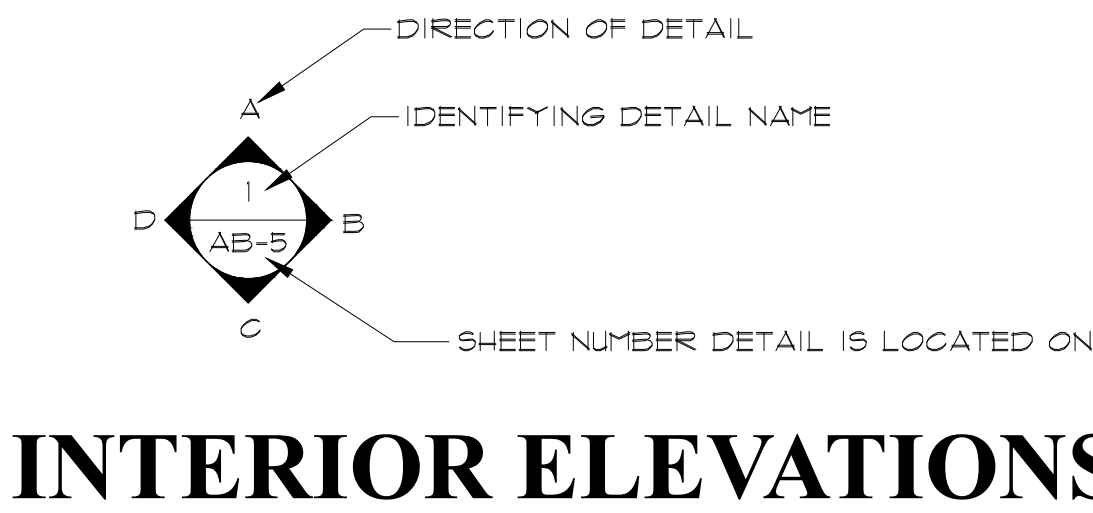

INTERIOR ELEVATIONS

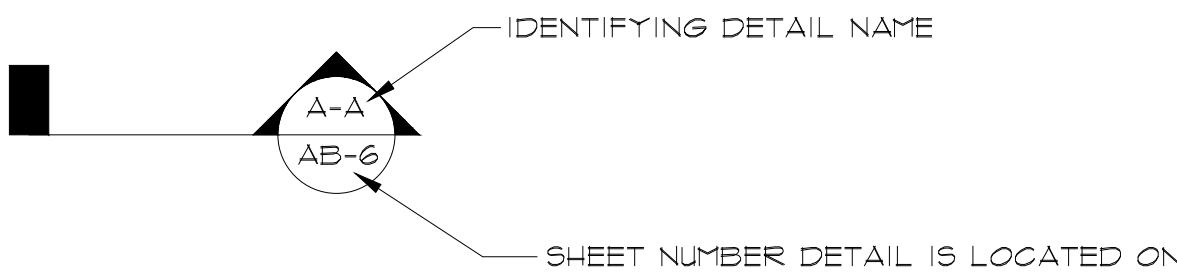

BUILDING SECTION

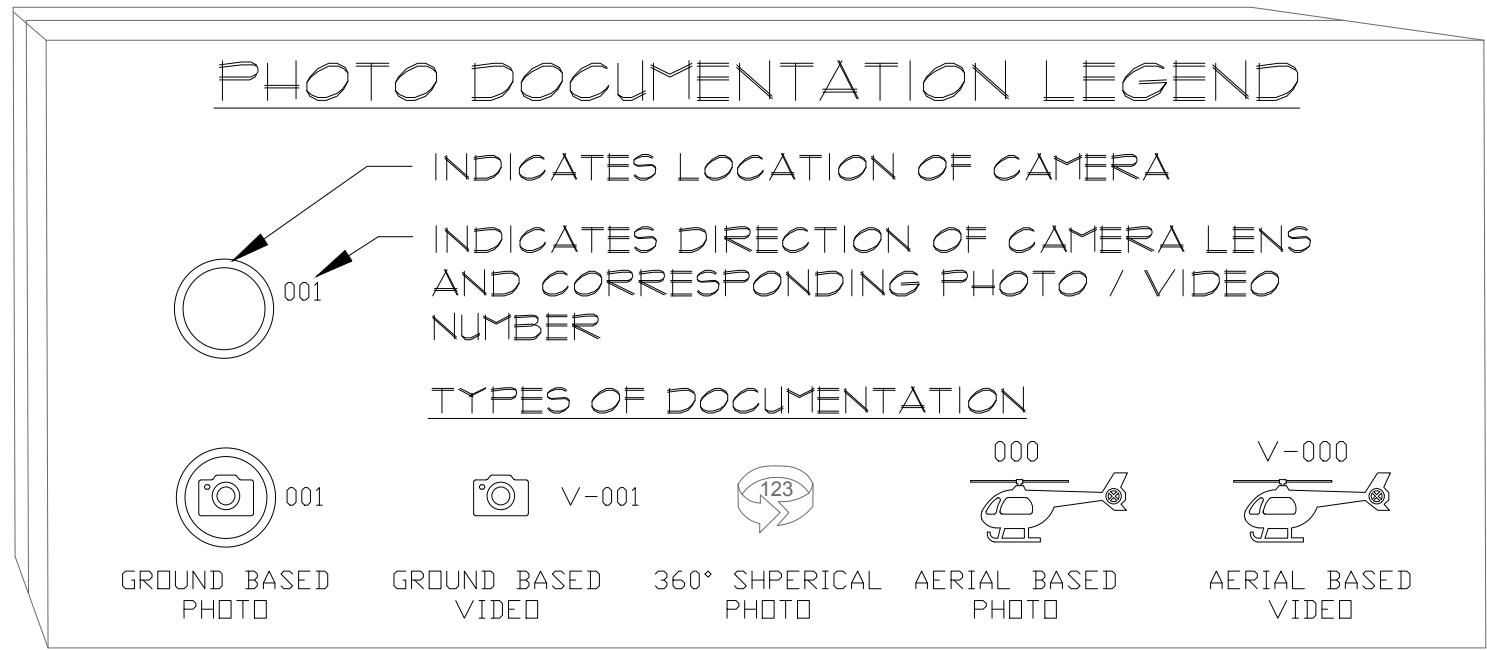


ARCHITECTURAL AS BUILT

Jay Littleton Ballpark

ONTARIO, CA 91764


01	100% SUBMISSION	SEE COVER SHEET
NO.	ISSUES REVISIONS	DATE
SHEET TITLE		
HL	PROJECT MANAGER	
HL	PROJECT DIRECTOR	
012317-1	PROJECT NUMBER	
NOT TO SCALE		
CL	DRAWN BY	
SHEET NUMBER		

SL

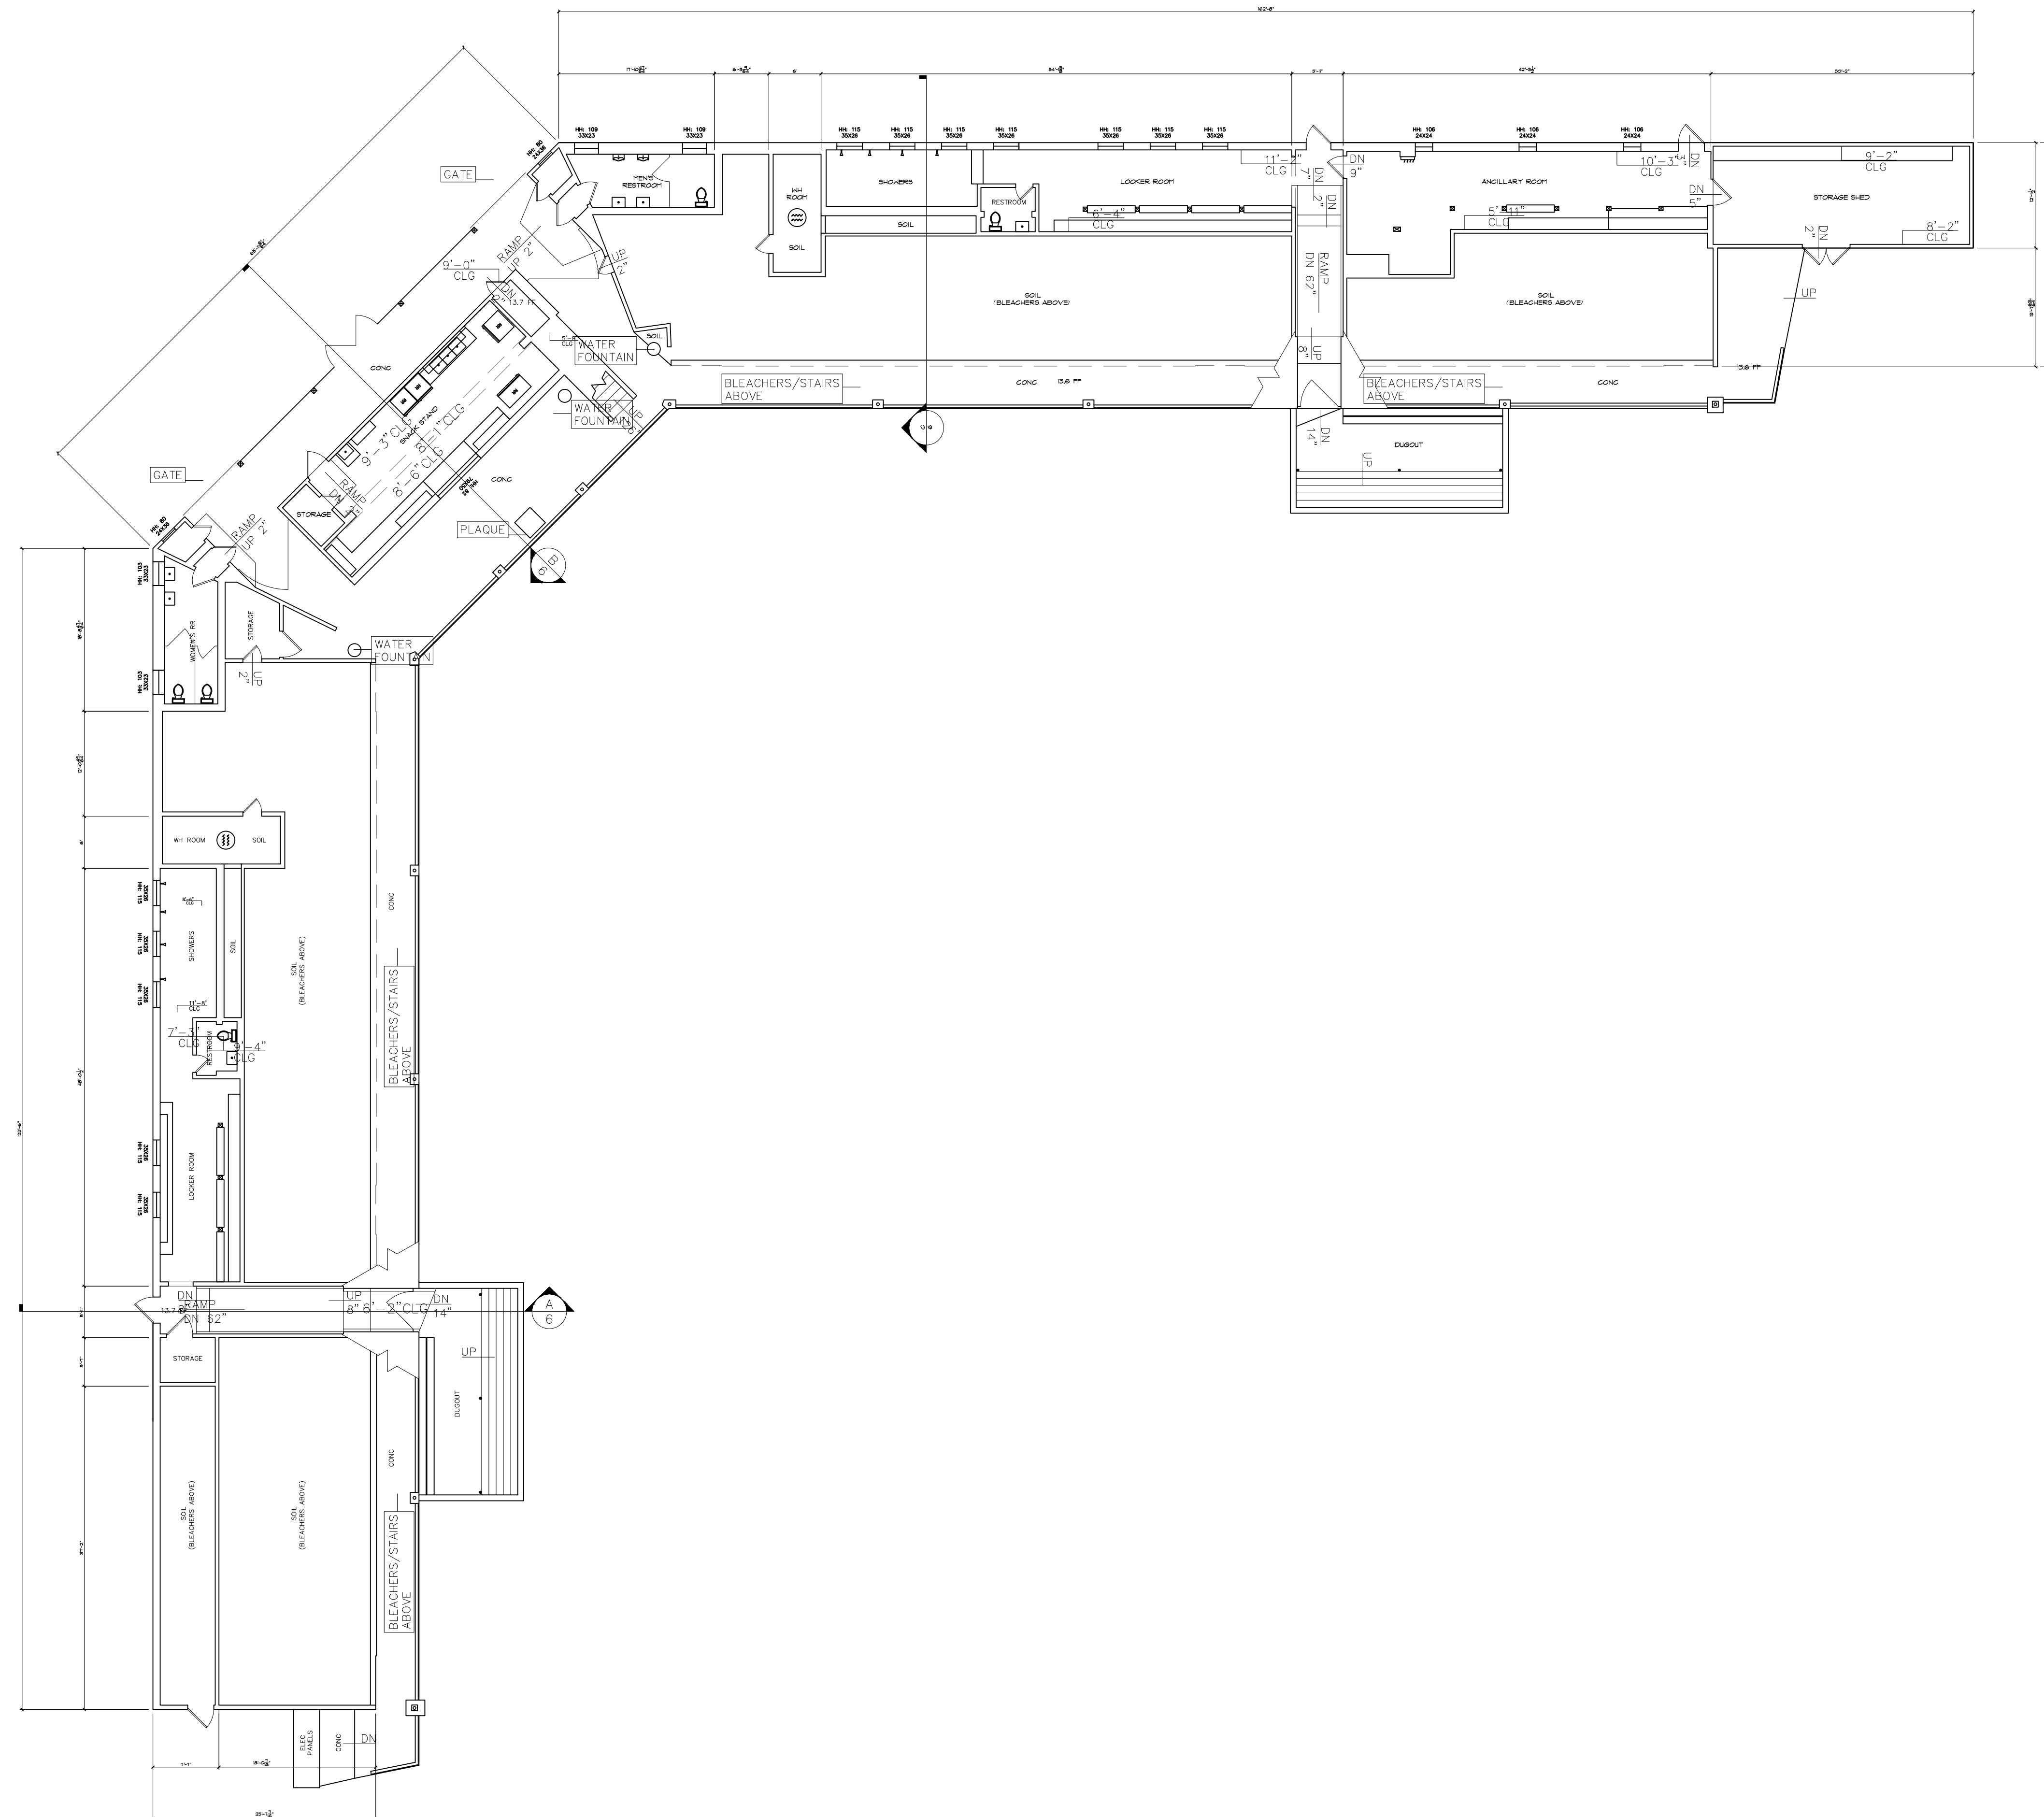


ARCHITECTURAL AS BUILT
Jay Littleton Ballpark
ONTARIO, CA 91764


01	100% SUBMISSION	SEE COVER SHEET
NO.	ISSUES REVISIONS	DATE
		SHEET TITLE
FLOOR PLAN LEVEL 1		
HL	PROJECT MANAGER	
HL	PROJECT DIRECTOR	
012317-1	PROJECT NUMBER	
3/32"=1'-0"	SCALE	
CL	DRAWN BY	
		SHEET NUMBER

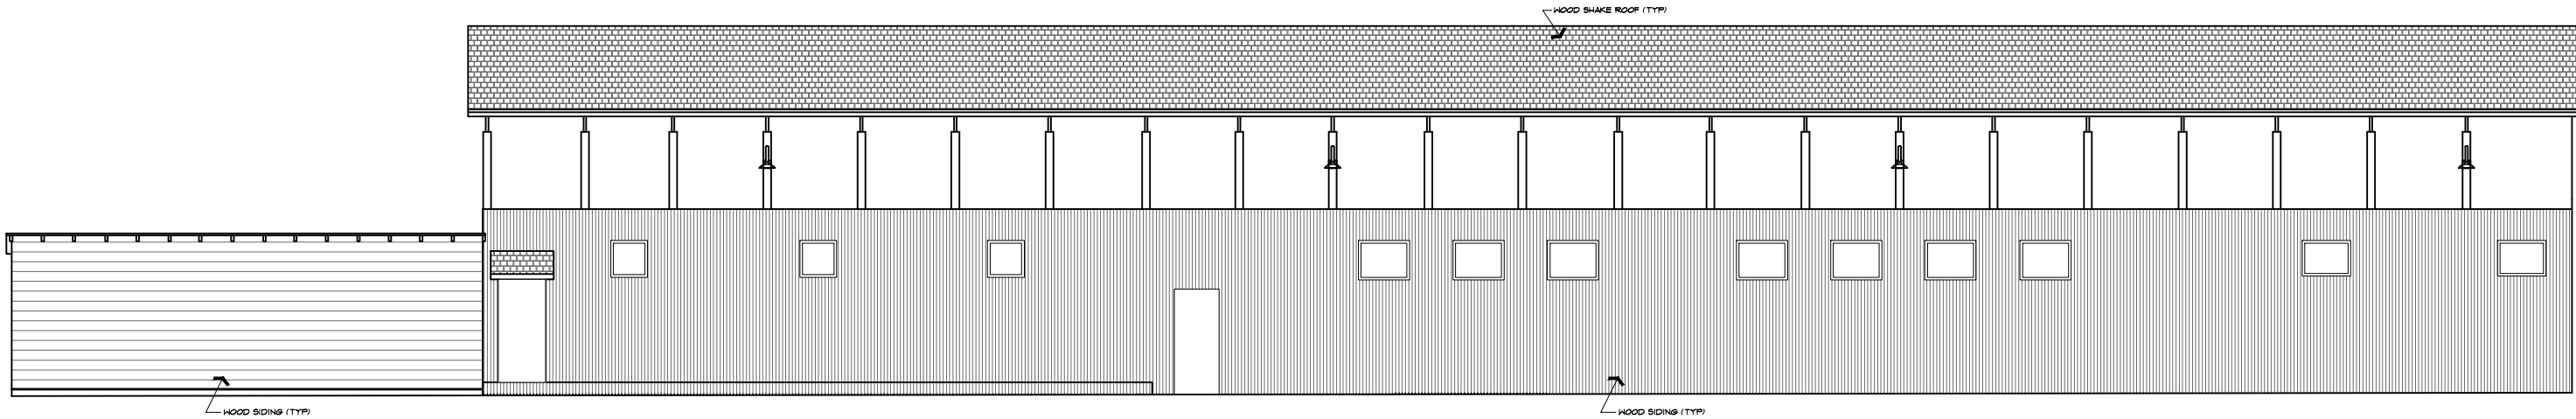


SOUTH ELEVATION

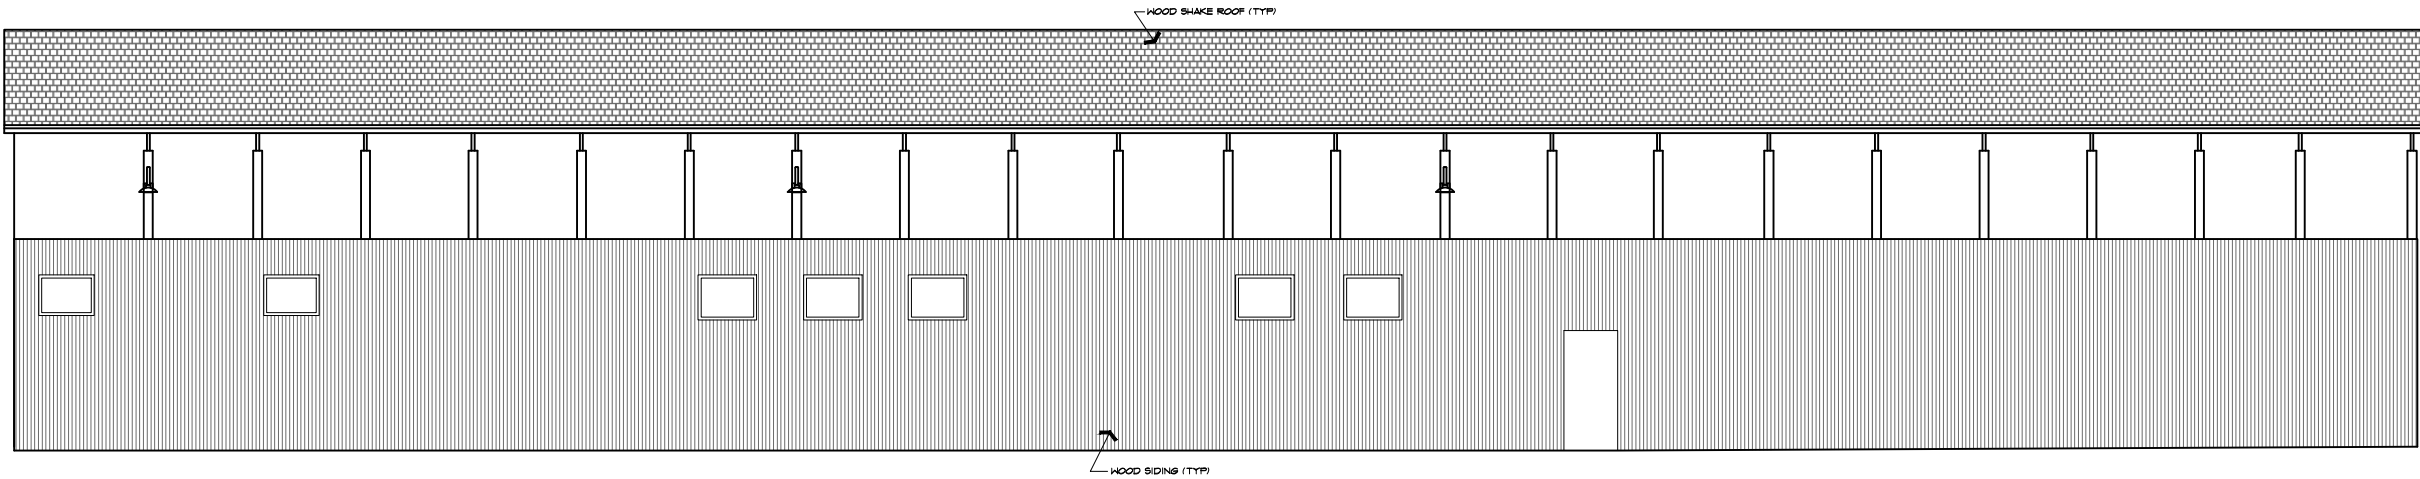

EAST ELEVATION

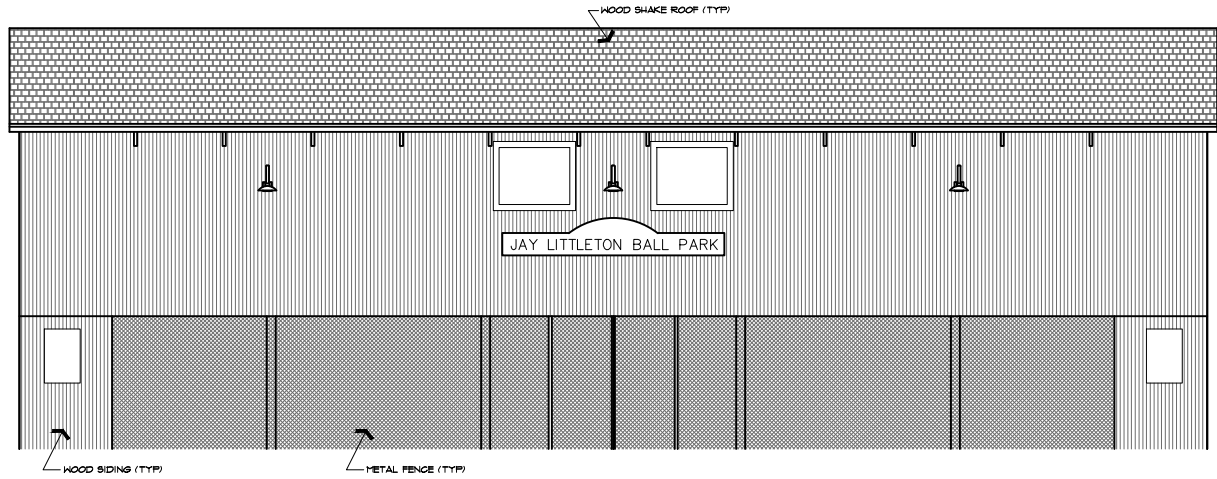

SOUTHEAST ELEVATION

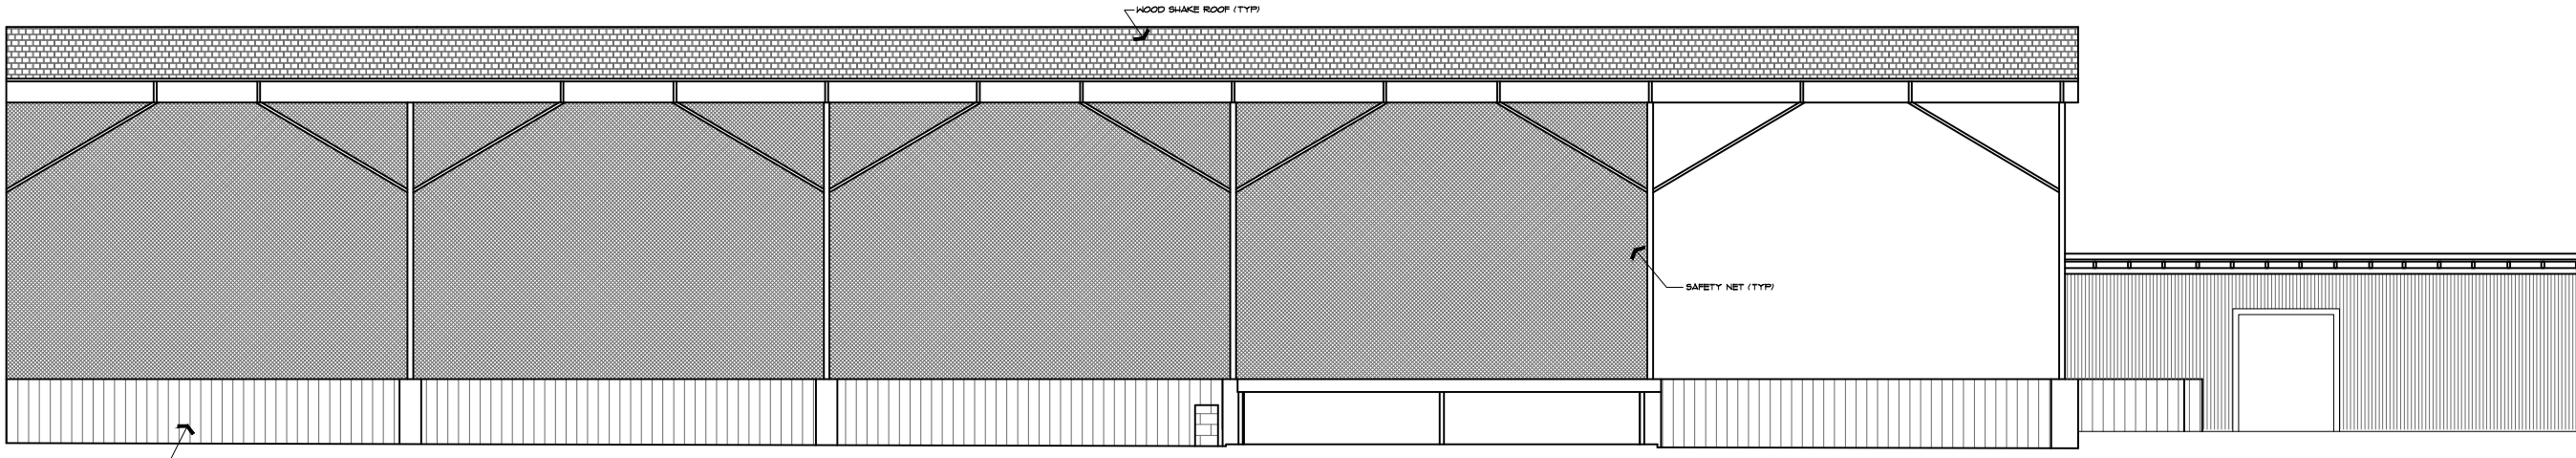

NORTH ELEVATION

As BUILT

PROFESSIONALS

www.asbuiltprofessionals.com

A DIVISION OF:

AEC

CONSULTANTS INC

844.272.8458

844 AS BUILT

@ 2018 AEC CONSULTANTS INC


ARCHITECTURAL AS BUILT

Jay Littleton Ballpark


ONTARIO, CA 91764

01	100% SUBMISSION	SEE COVER SHEET
NO.	ISSUES REVISIONS	DATE
SHEET TITLE		
EXTERIOR ELEVATIONS		
HL	PROJECT MANAGER	
HL	PROJECT DIRECTOR	
012317-1	PROJECT NUMBER	
3/32"=1'-0"	SCALE	
CL	DRAWN BY	
SHEET NUMBER		


AB-3

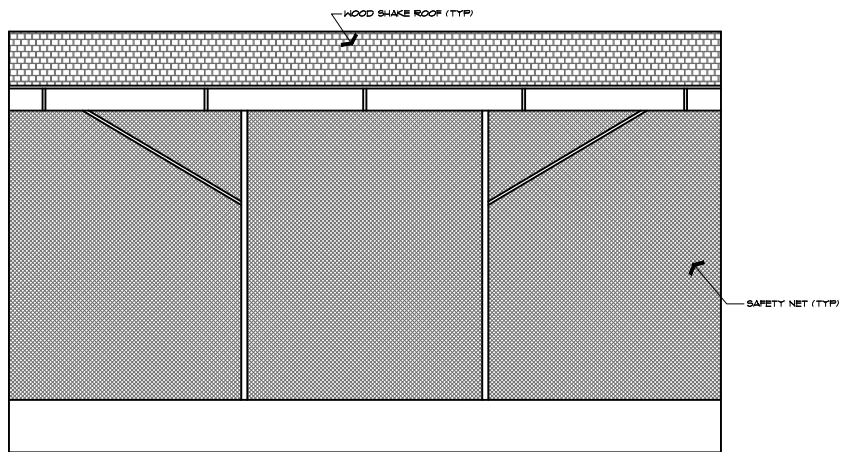


NORTHWEST ELEVATION

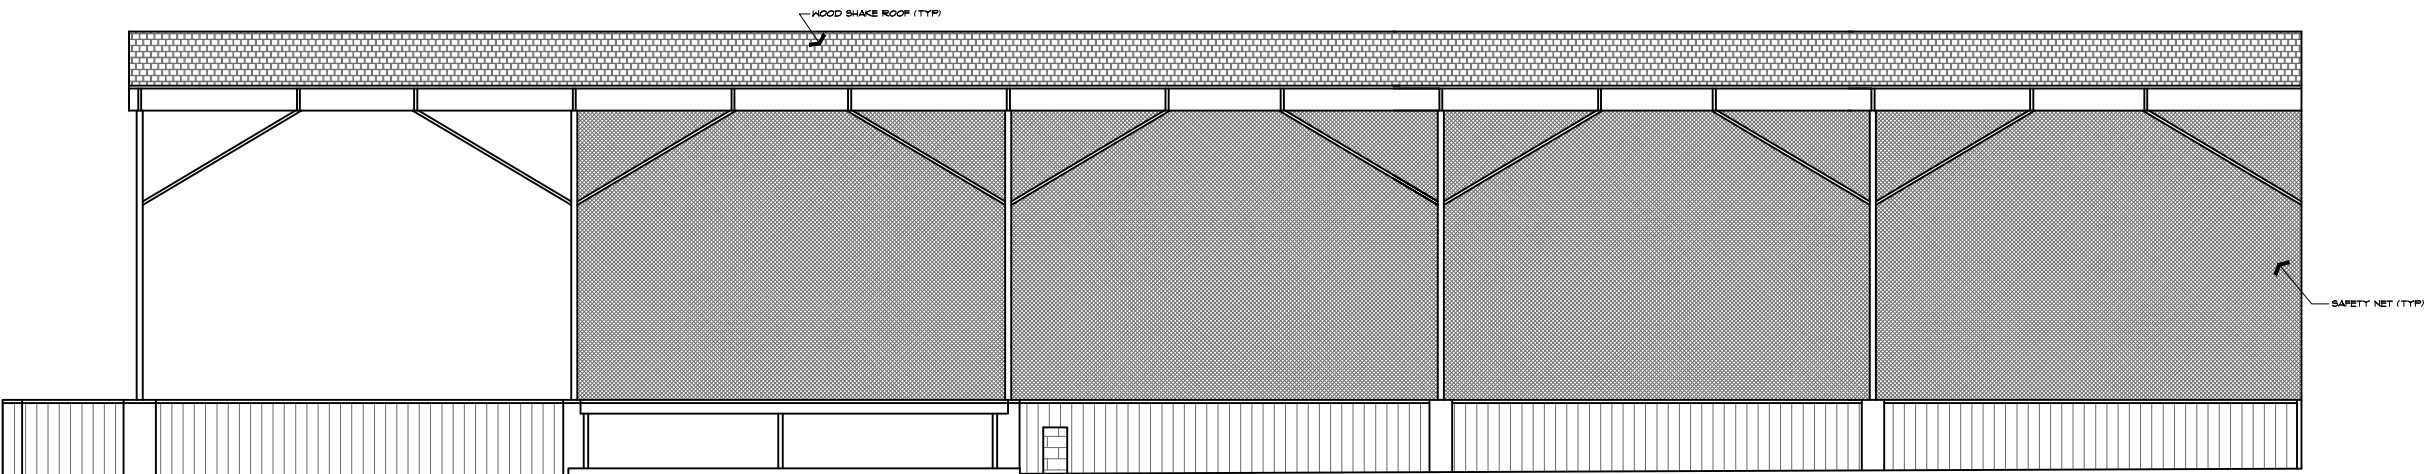


WEST ELEVATION

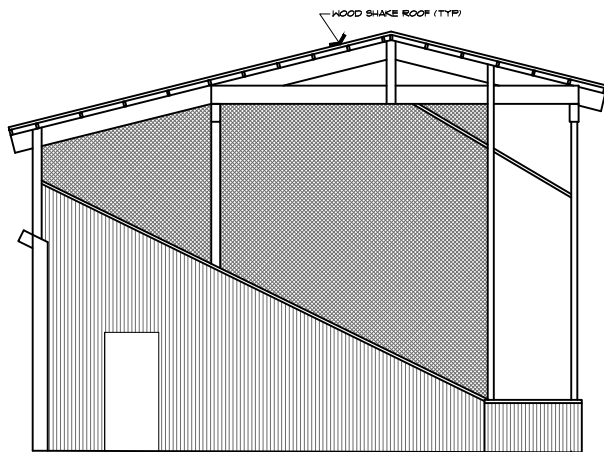

NORTH ELEVATION

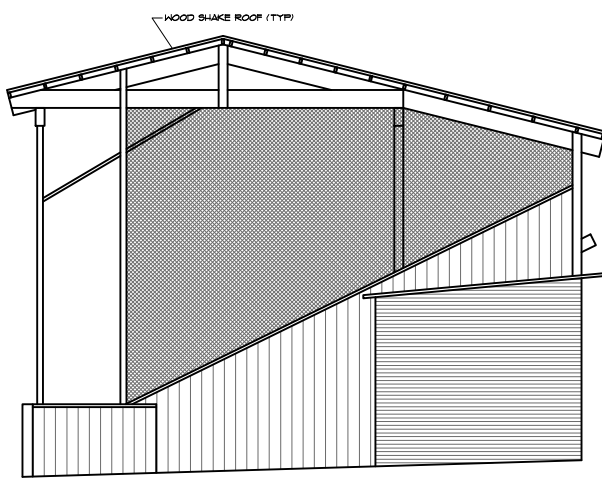

WEST ELEVATION

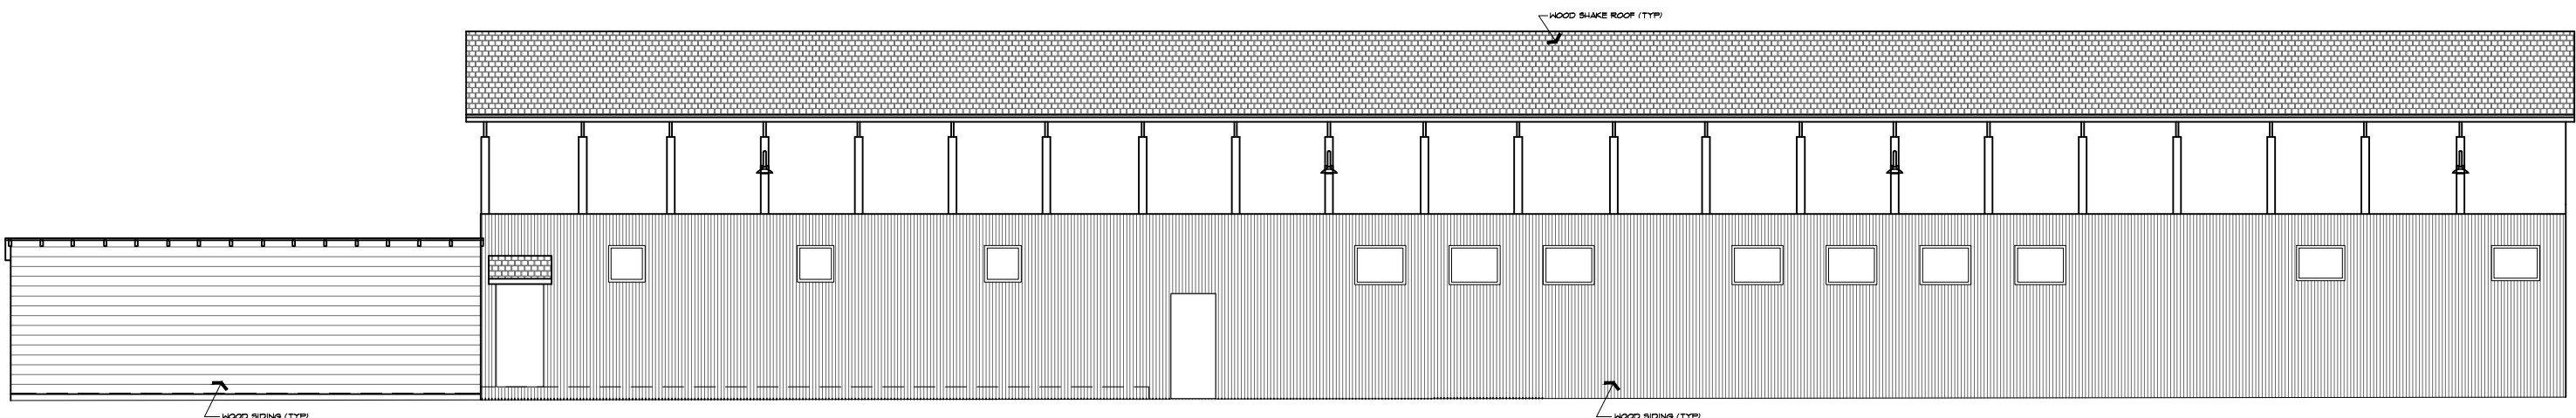

SOUTH ELEVATION

As BUILT

PROFESSIONALS

www.asbuiltprofessionals.com

A DIVISION OF:

AEC

CONSULTANTS INC

844.272.8458

844 AS BUILT

© 2018 AEC CONSULTANTS INC


ARCHITECTURAL AS BUILT

Jay Littleton Ballpark

ONTARIO, CA 91764

01	100% SUBMISSION	SEE COVER SHEET
NO.	ISSUES REVISIONS	DATE
		SHEET TITLE
EXTERIOR ELEVATIONS		
HL	PROJECT MANAGER	
HL	PROJECT DIRECTOR	
012317-1	PROJECT NUMBER	
3/32"=1'-0"	SCALE	
CL	DRAWN BY	
		SHEET NUMBER

AB-4

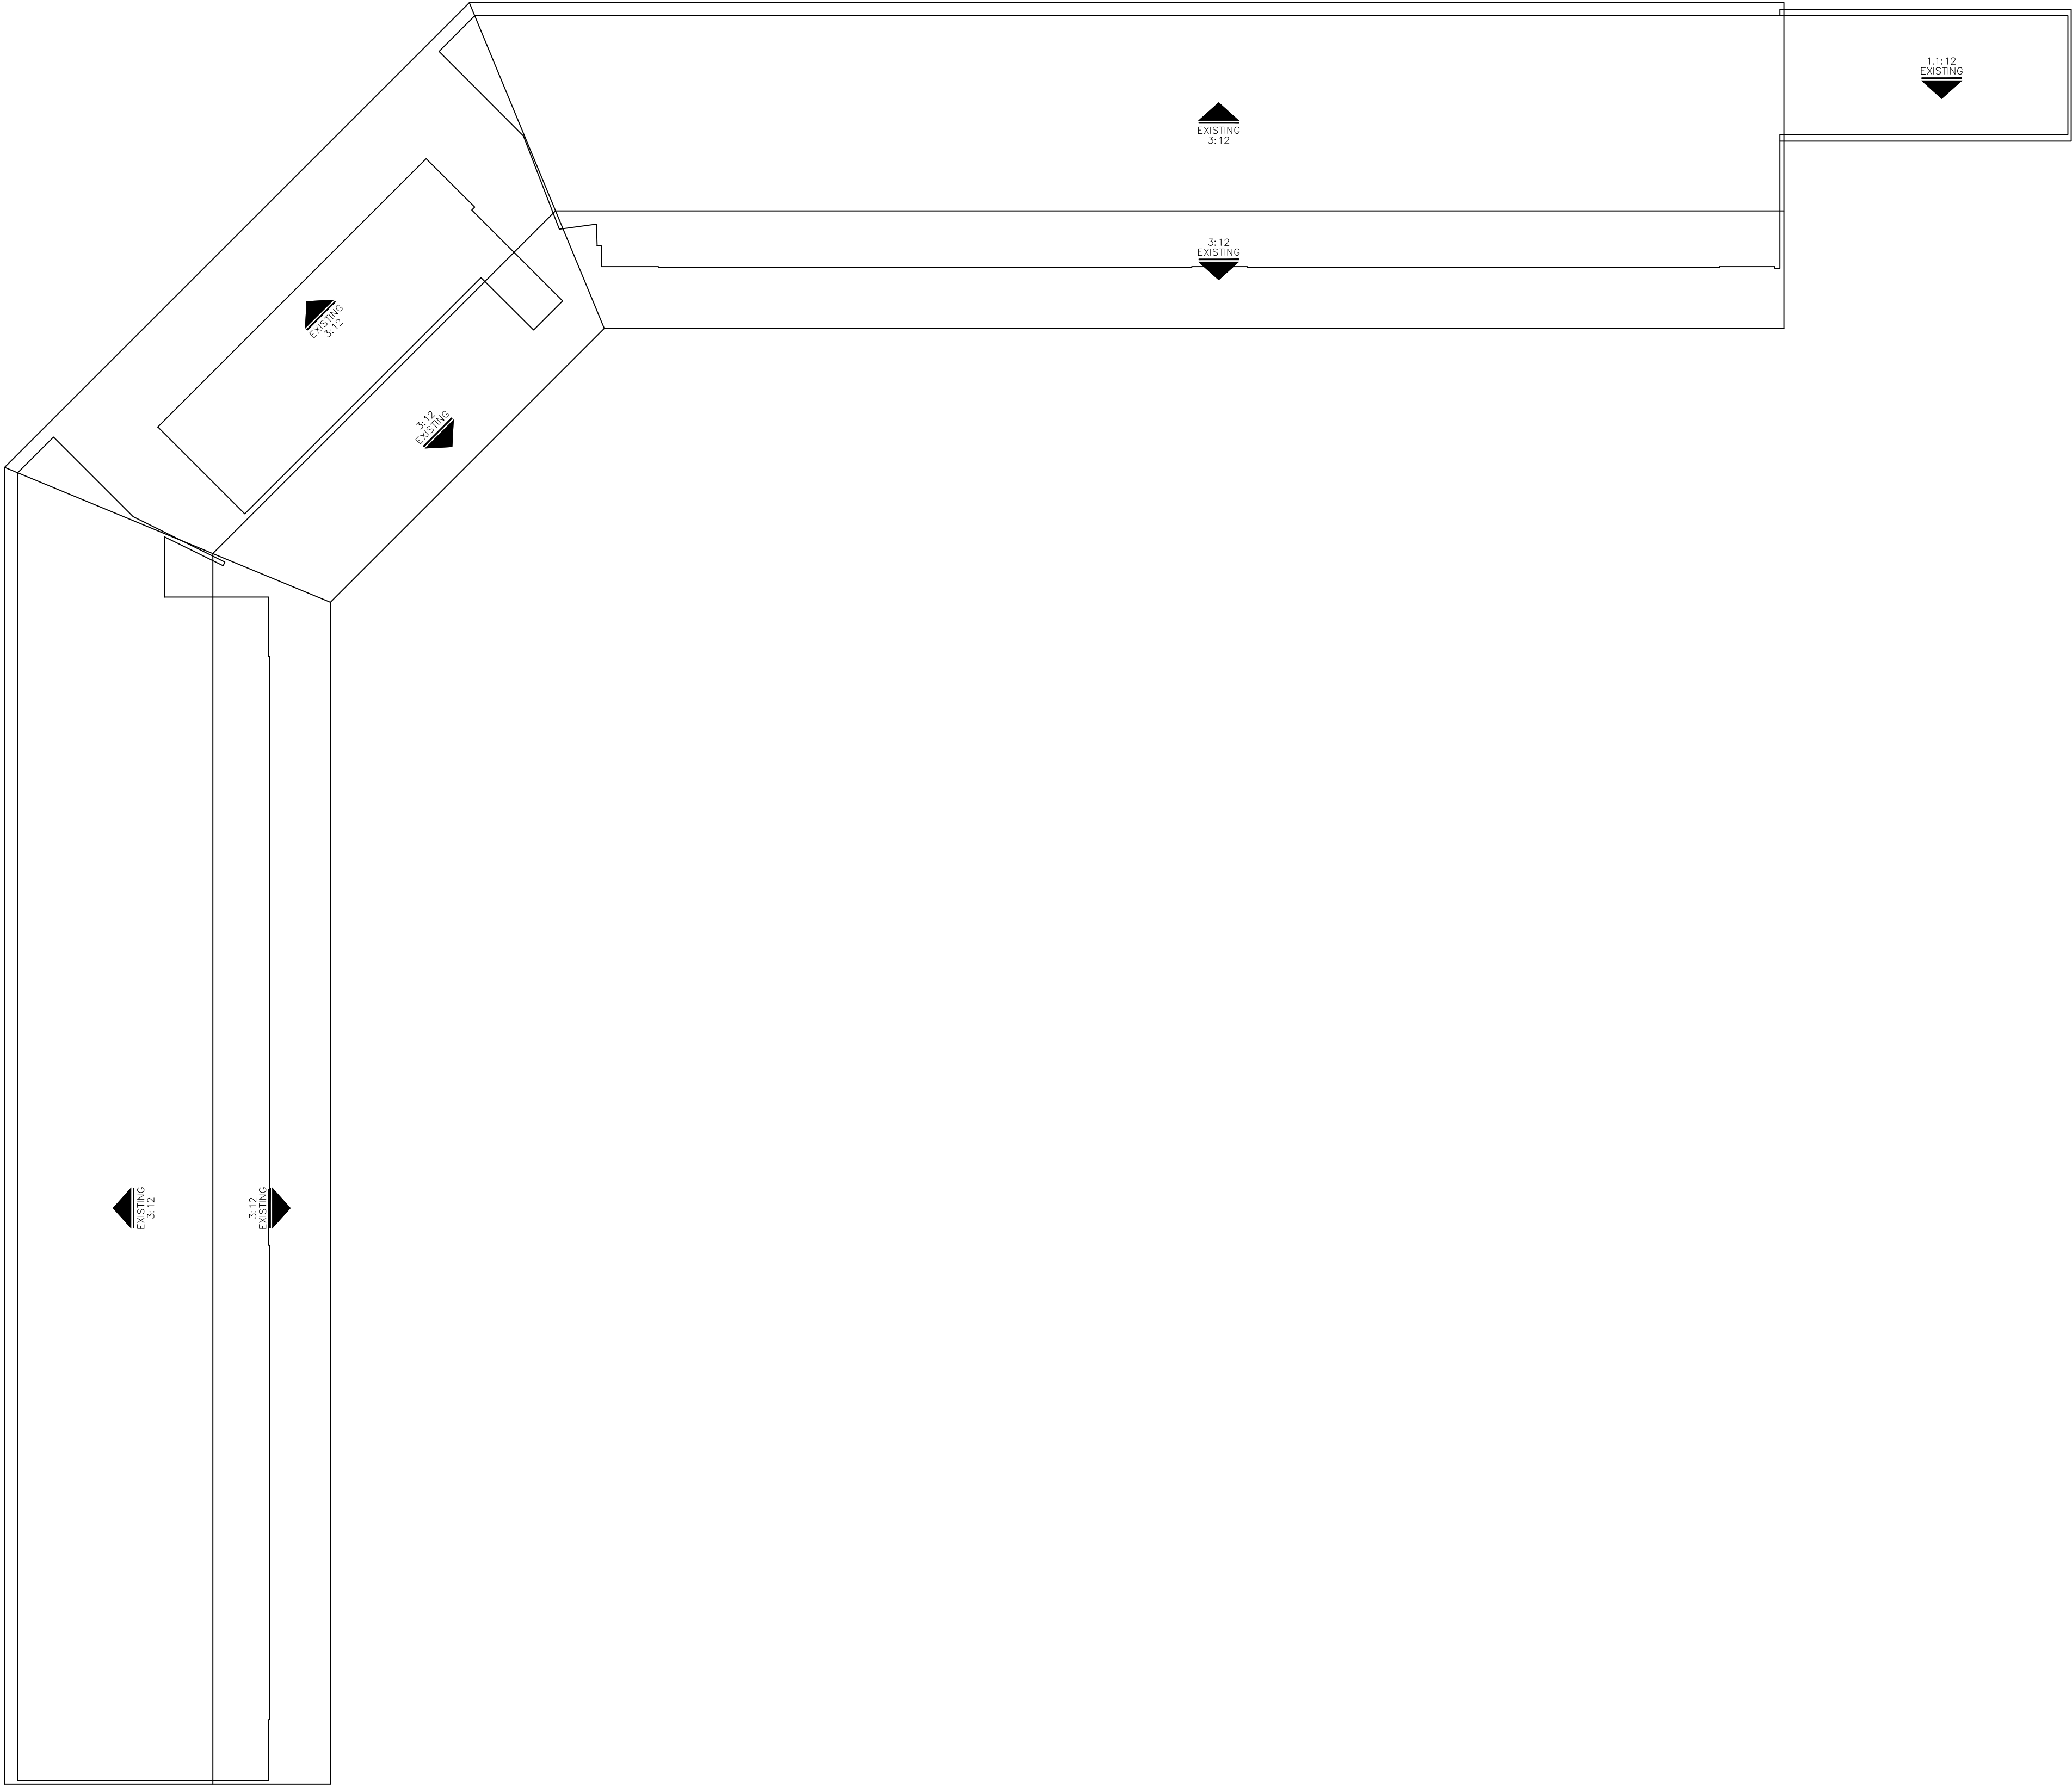

As BUILT

PROFESSIONALS

www.asbuiltprofessionals.com

A DIVISION OF:

AEC

CONSULTANTS INC

844.272.8458

844 AS BUILT

@ 2018 AEC CONSULTANTS INC


ARCHITECTURAL AS BUILT

Jay Littleton Ballpark


ONTARIO, CA 91764

01	100% SUBMISSION	SEE COVER SHEET
NO.	ISSUES REVISIONS	DATE
		SHEET TITLE
ROOF PLAN		
HL	PROJECT MANAGER	
HL	PROJECT DIRECTOR	
012317-1	PROJECT NUMBER	
3/32"=1'-0"	SCALE	
CL	DRAWN BY	
	SHEET NUMBER	


AB-5

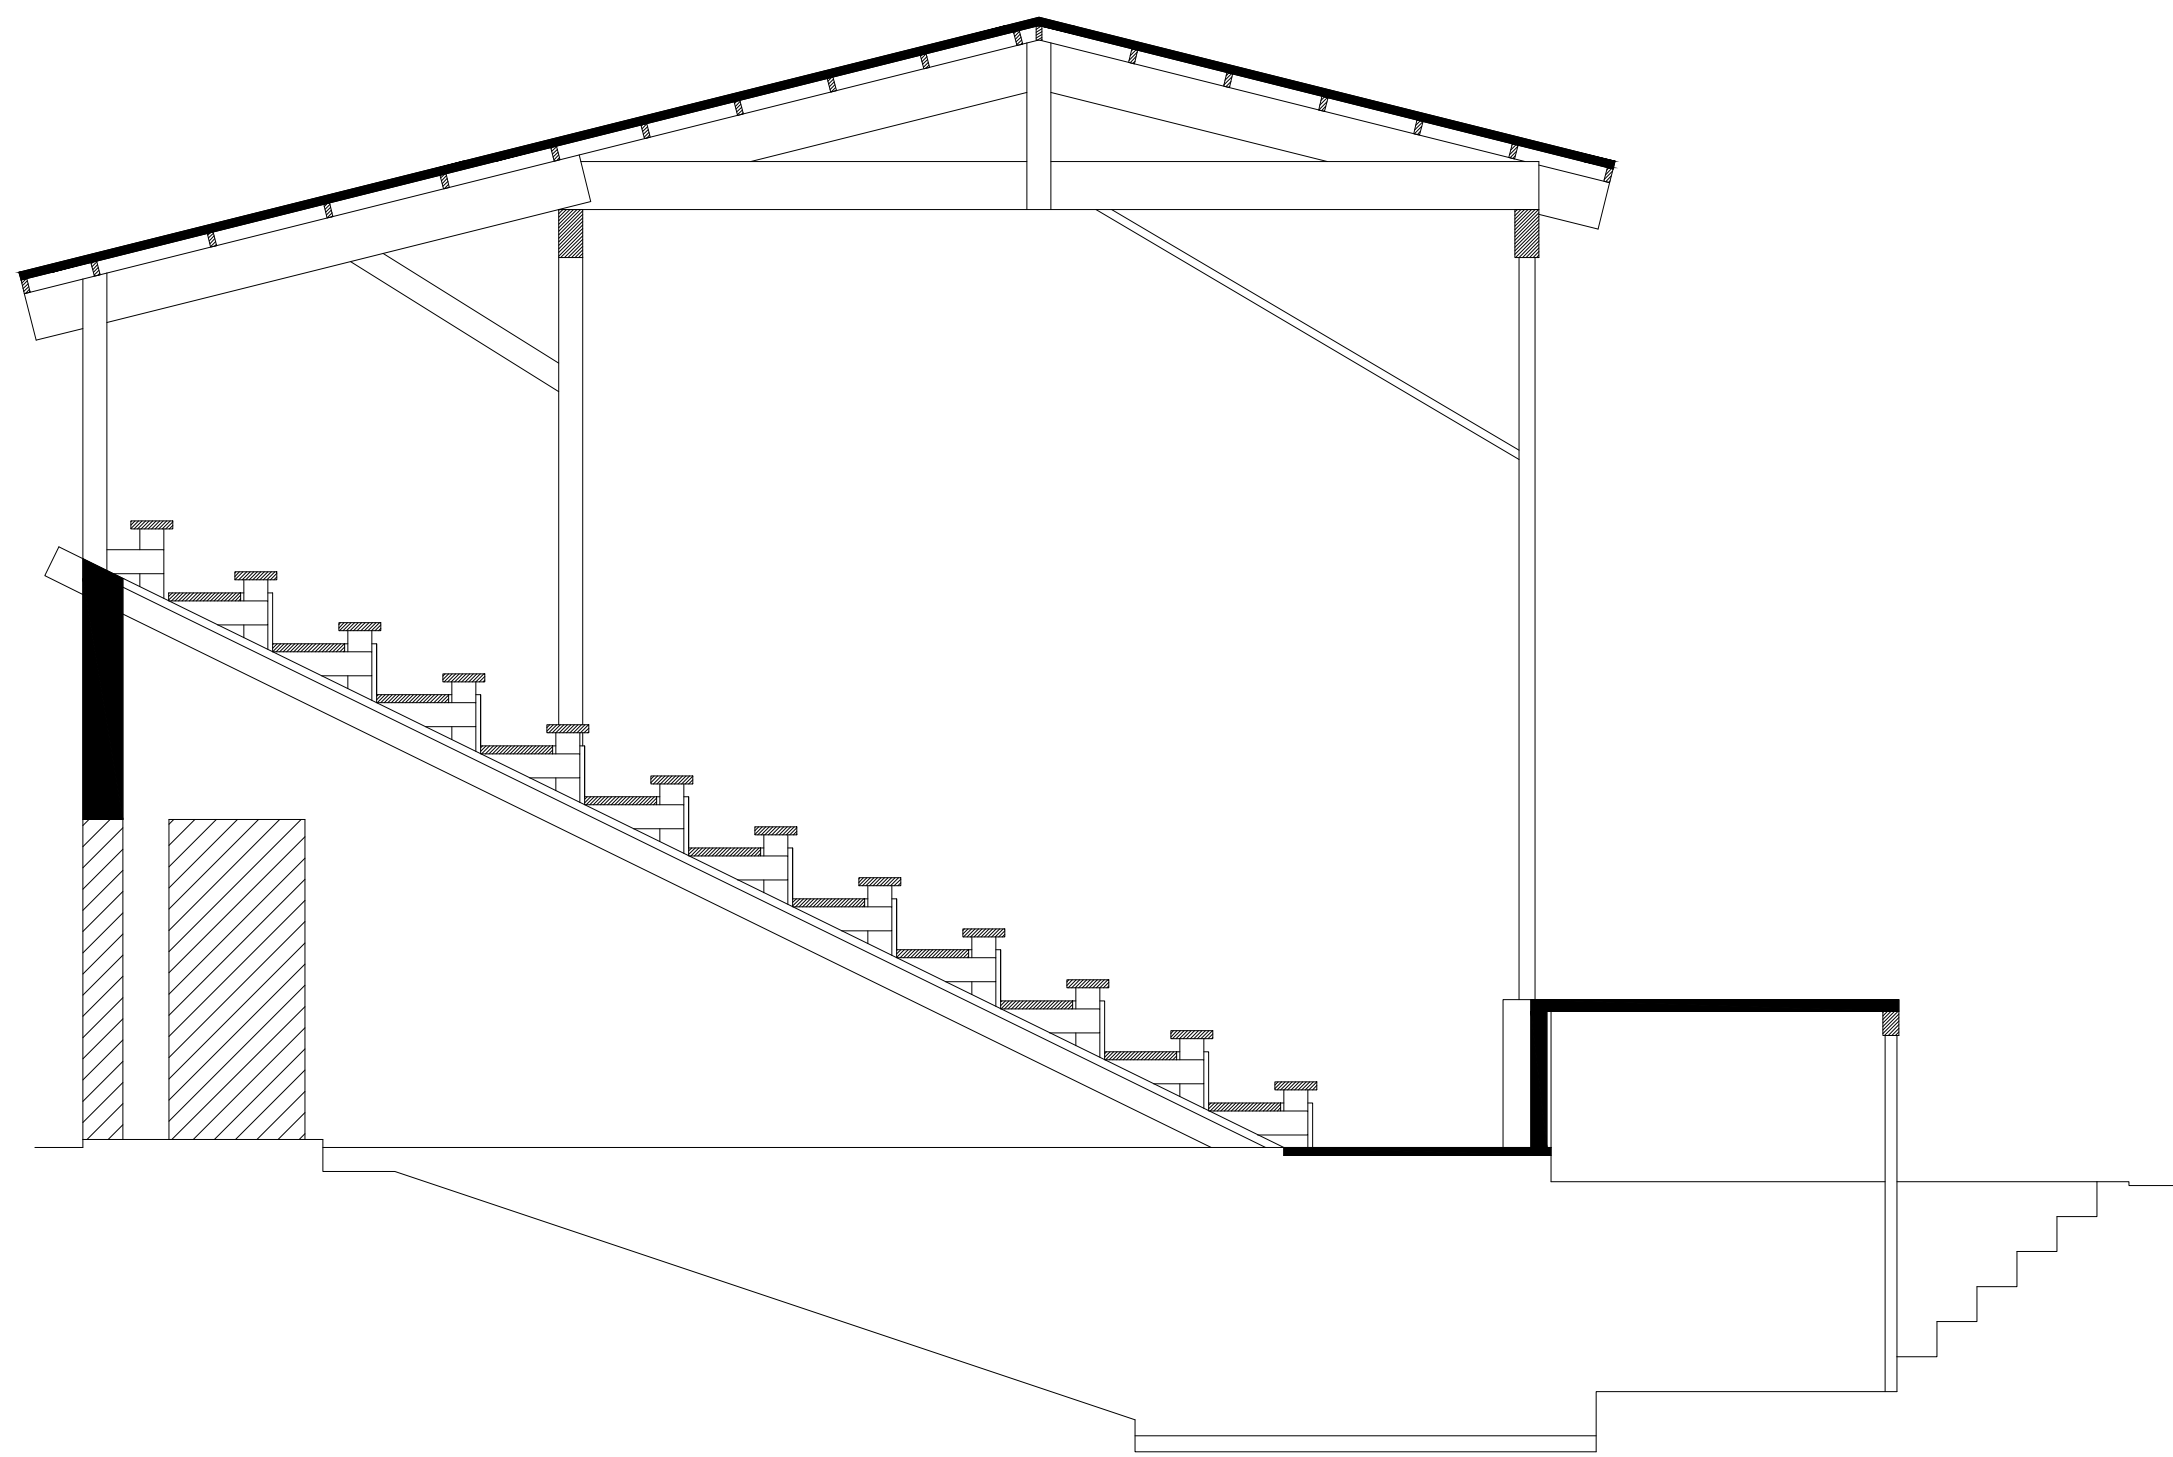

SECTION A

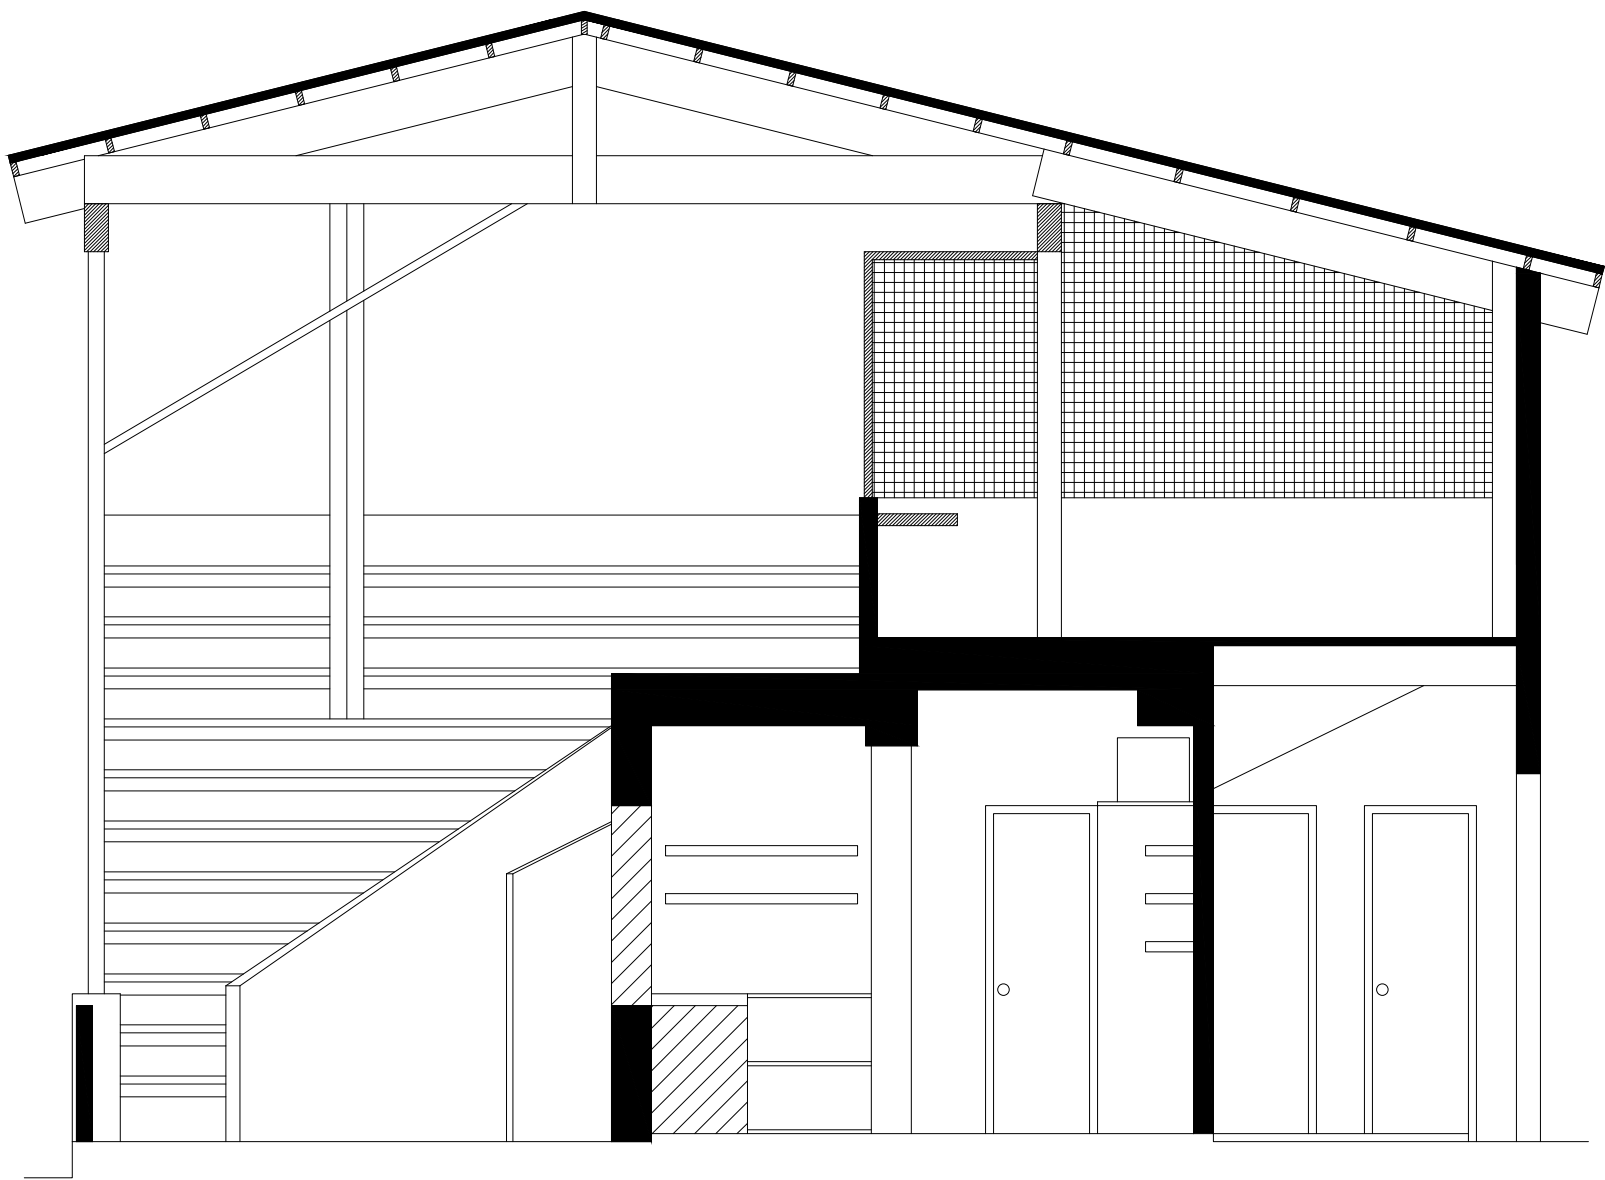

SECTION B

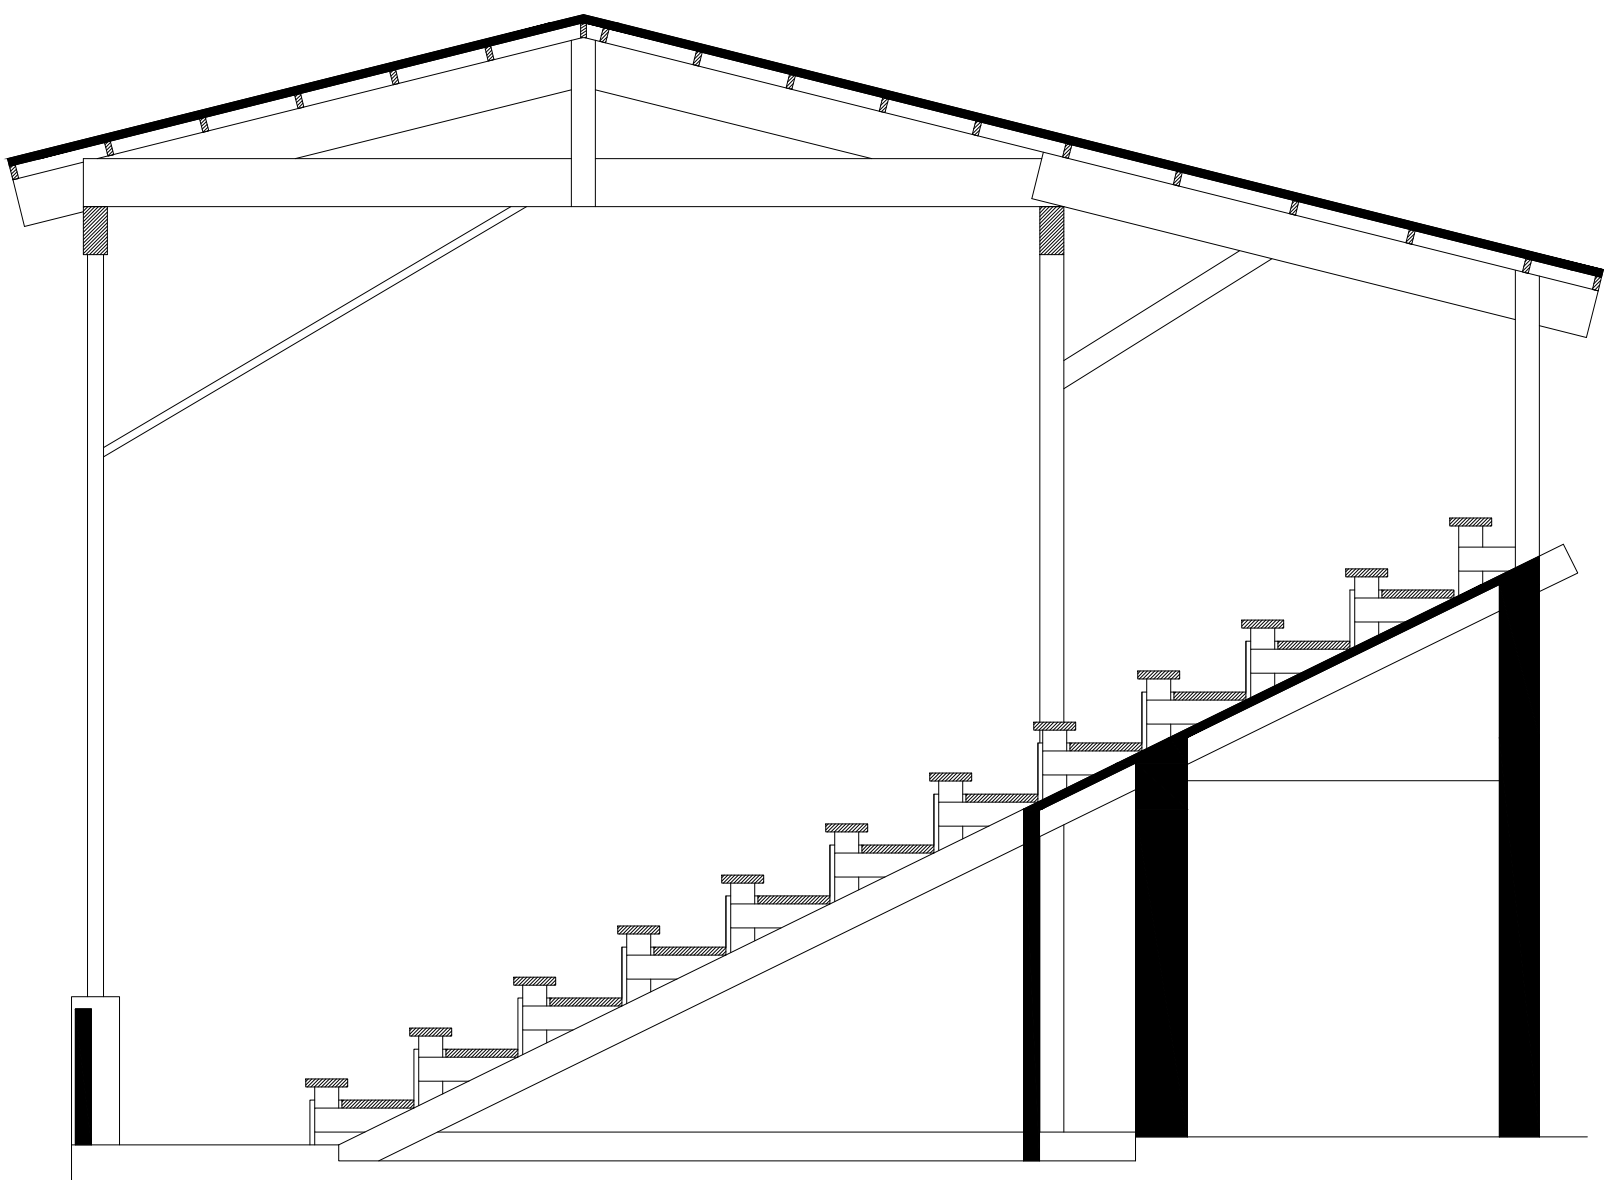

SECTION C

As BUILT

PROFESSIONALS

www.asbuiltprofessionals.com

A DIVISION OF:

AEC

CONSULTANTS INC

844.272.8458

844 AS BUILT

© 2018 AEC CONSULTANTS INC.


ARCHITECTURAL AS BUILT

Jay Littleton Ballpark

ONTARIO, CA 91764

01	100% SUBMISSION	SEE COVER SHEET
NO.	ISSUES REVISIONS	DATE
SHEET TITLE		
BUILDING SECTIONS		
HL	PROJECT MANAGER	
HL	PROJECT DIRECTOR	
012317-1	PROJECT NUMBER	
1/4"=1'-0"	SCALE	
CL	DRAWN BY	
SHEET NUMBER		

AB-6

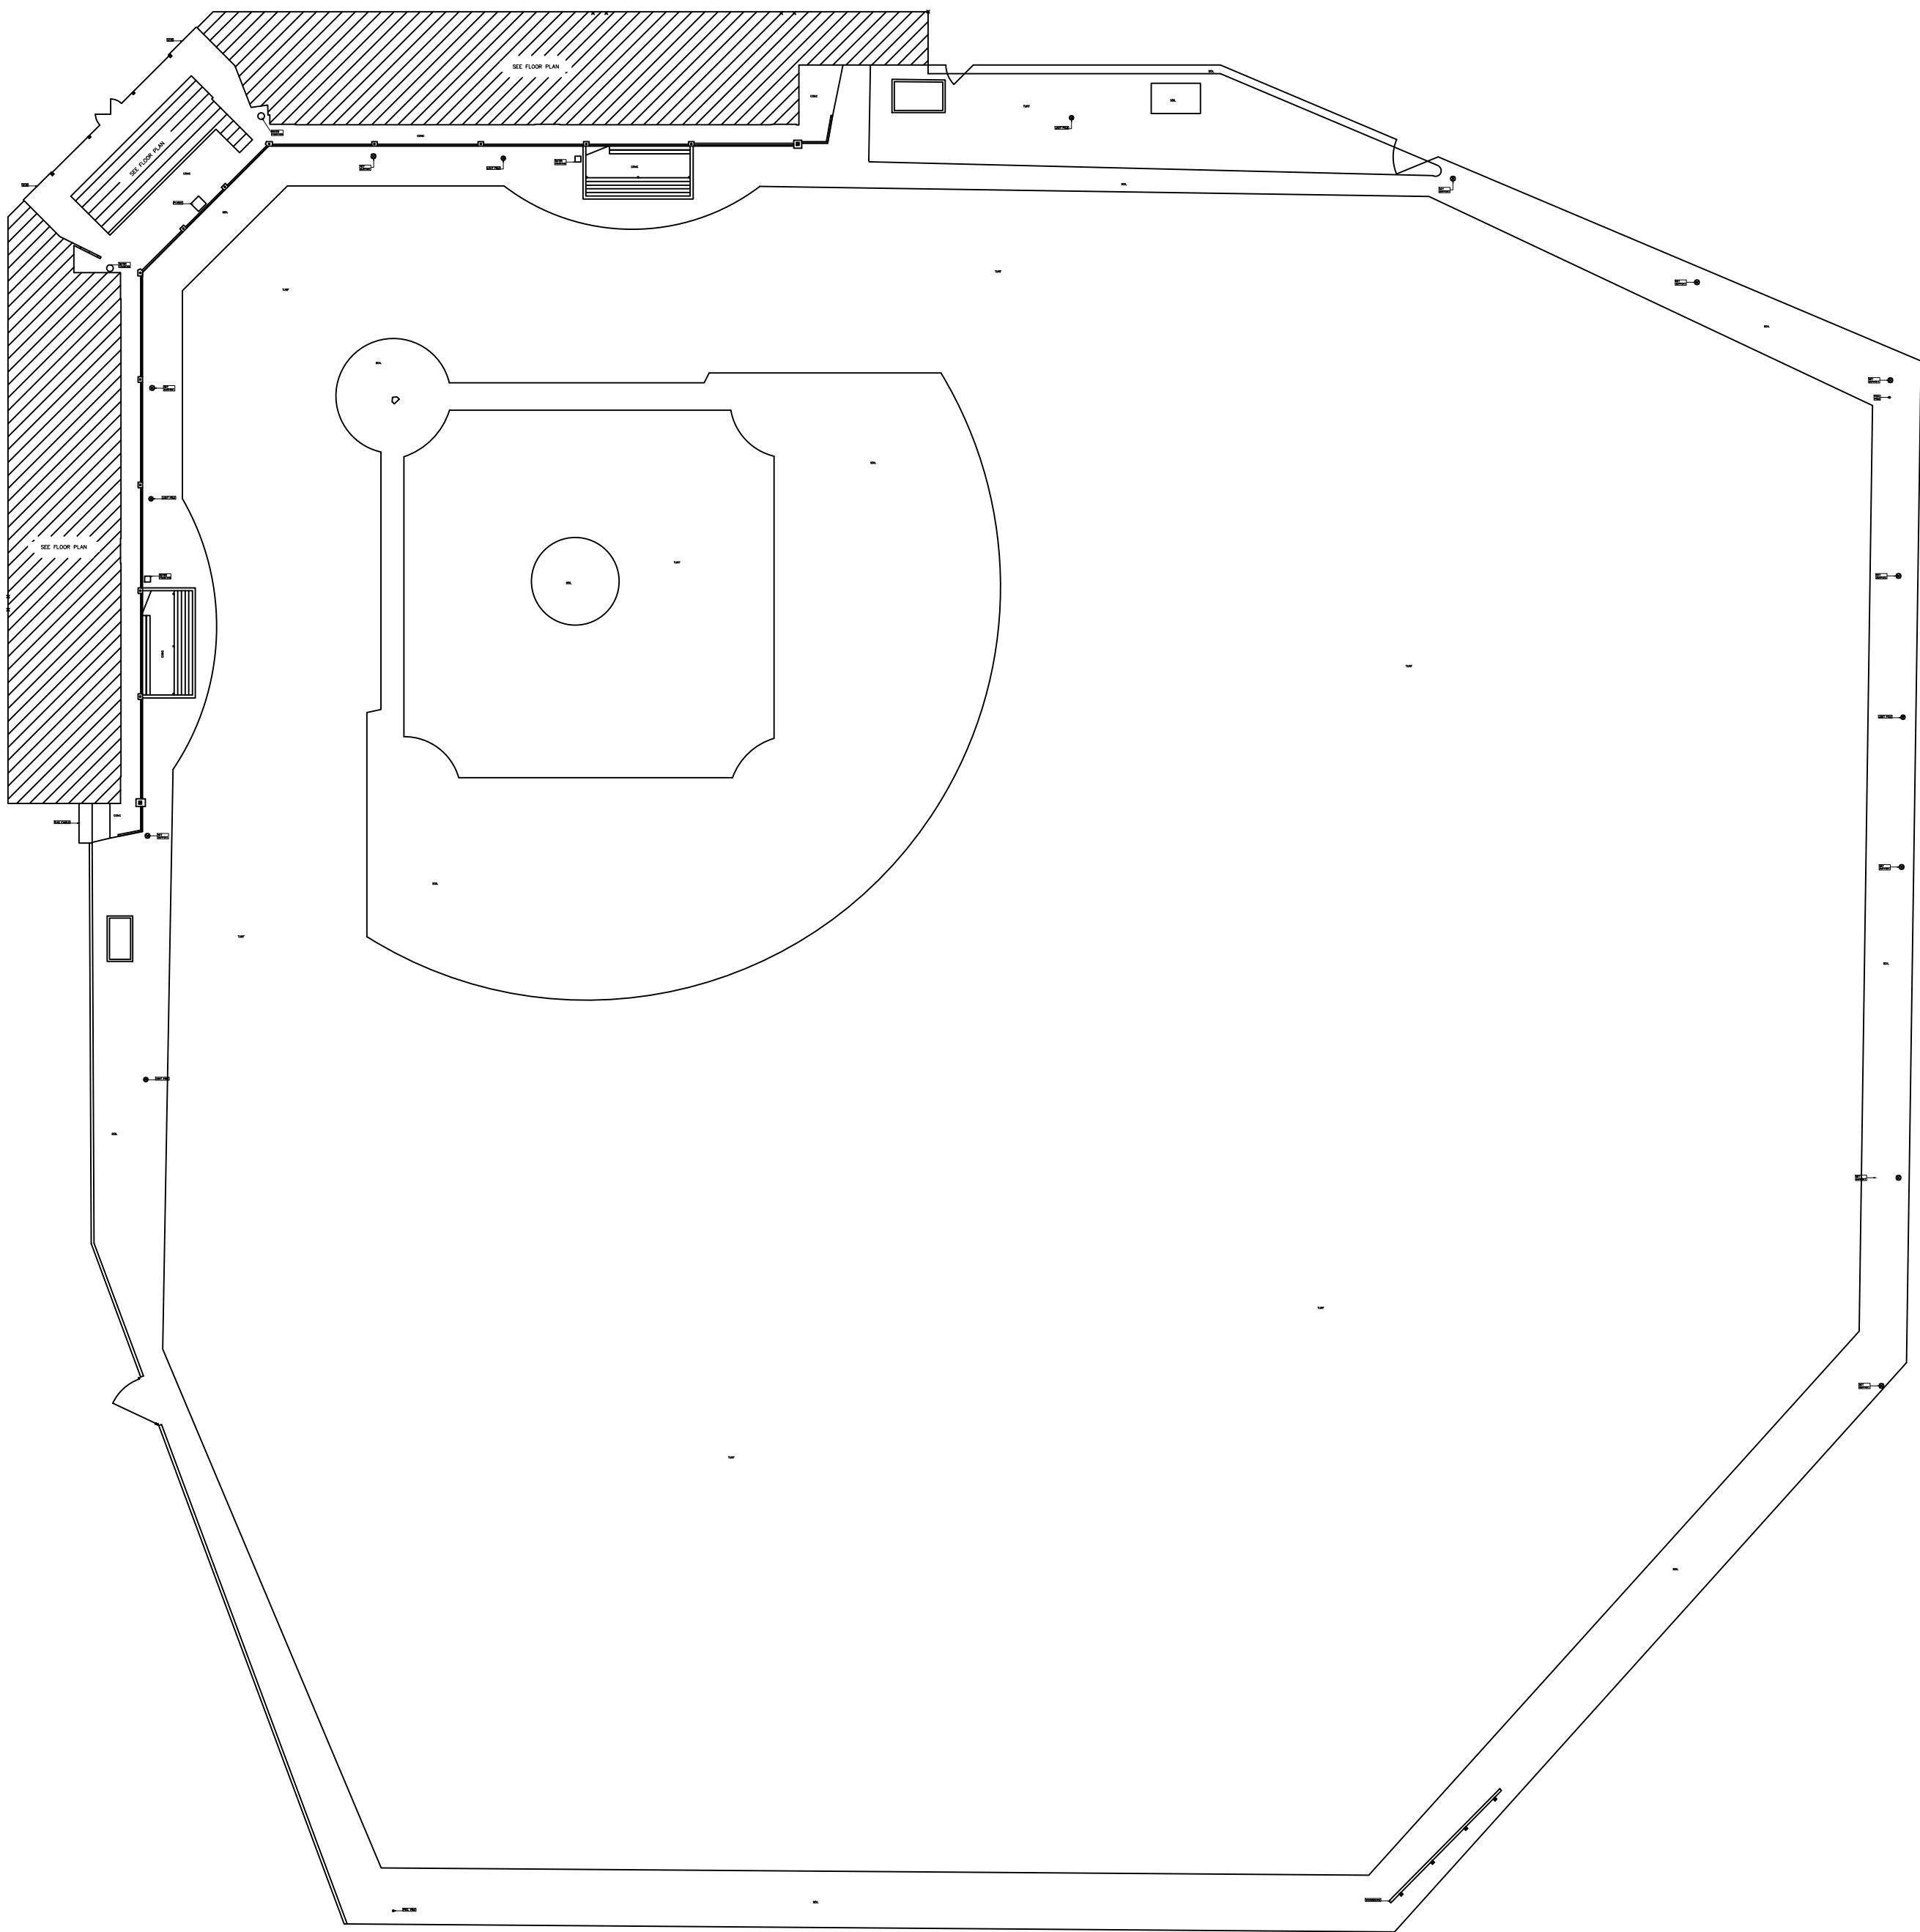

As BUILT

PROFESSIONALS

www.asbuiltprofessionals.com

A DIVISION OF:

AEC

CONSULTANTS INC

844.272.8458

844 AS BUILT

© 2018 AEC CONSULTANTS INC.

ARCHITECTURAL AS BUILT

Jay Littleton Ballpark

ONTARIO, CA 91764

01	100% SUBMISSION	SEE COVER SHEET
NO.	ISSUES REVISIONS	DATE
		SHEET TITLE
</		

AB-7