


Palm Beach Gardens, FL 33418



100% SUBMITTAL

Mechanical / Plumbing /Equipment Plans
 XM201 (Basement)
 XM202 (Main Level)
 XM203 (Mezzanines)
 XM204 (Roof Plan)

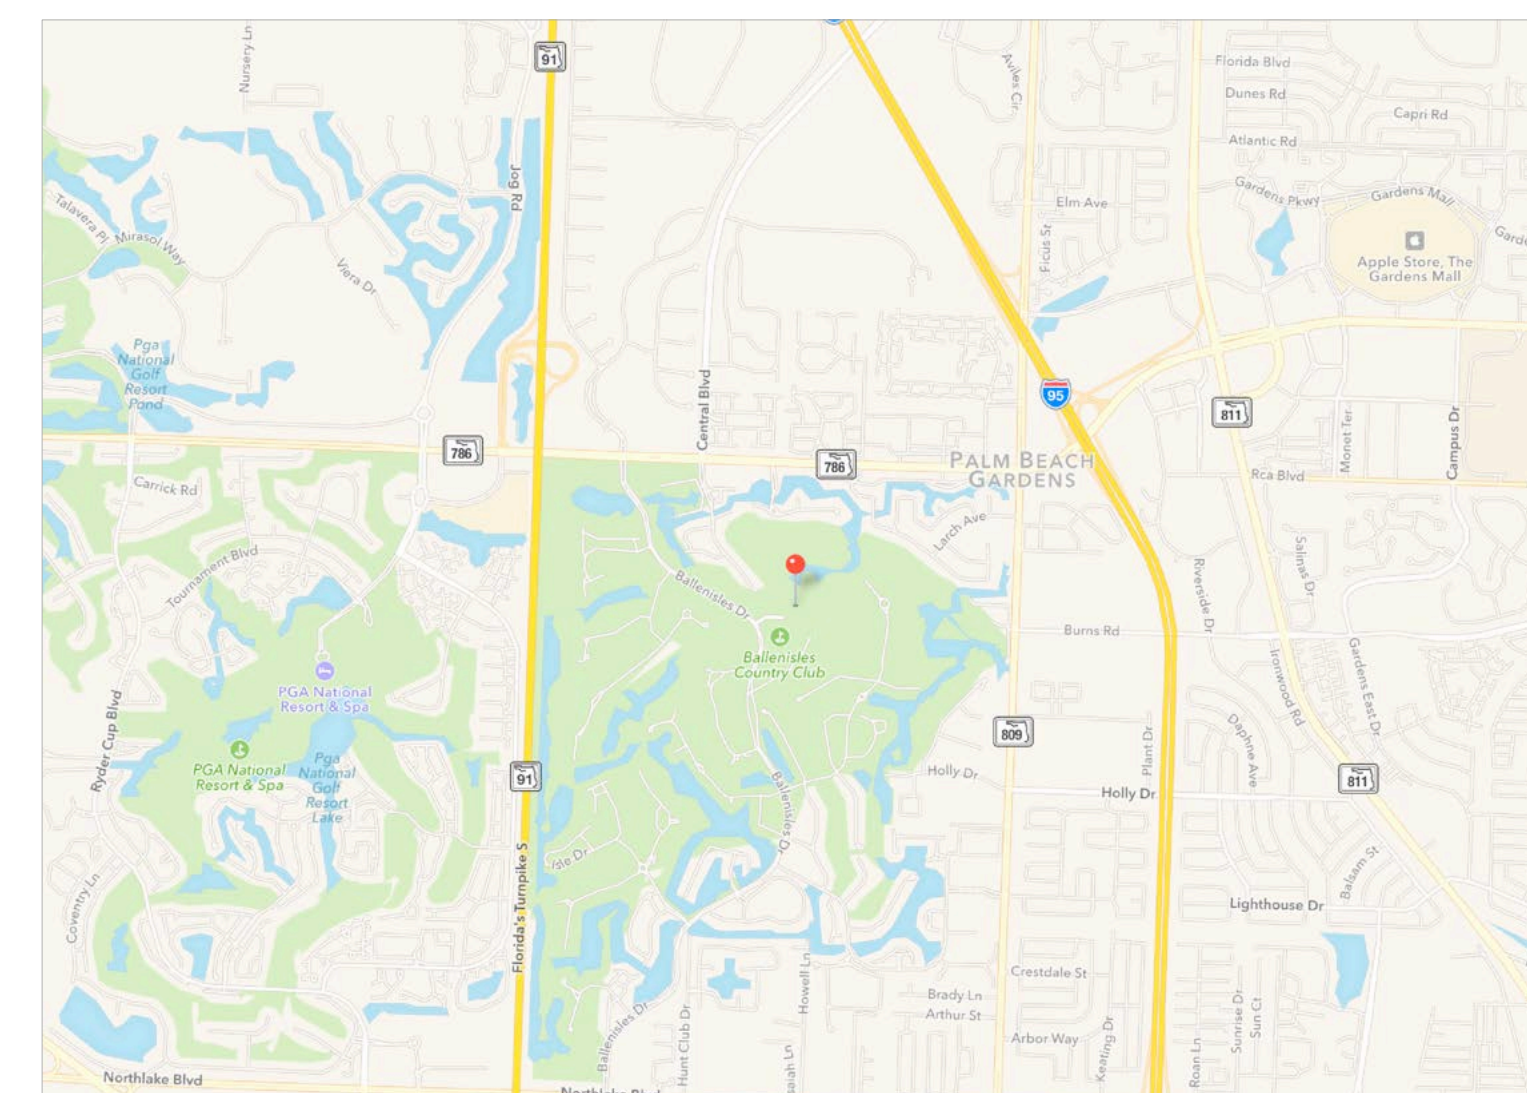


 **VICINITY MAP**
NTS



AS BUILT DOCUMENTATION: BALLENISLES COUNTRY CLUB

01		
NO.	ISSUES REVISIONS	DATE
		SHEET TITLE
COVER SHEET		
XX	PROJECT MANAGER	
HL	PROJECT DIRECTOR	
XX.XX.XX	PROJECT NUMBER	
AS NOTED	SCALE	
XX	DRAWN BY	
		SHEET NUMBER
C-1		

RCP		ELECTRIC	
	ON/OFF SWITCH		TELEPHONE OUTLET
	VENT		DOOR
	RECESSED ON LIGHT		TELEVISION
	PLASTER PATCH		RECEPTACLE
	INDIVIDUAL FLOOR		WATER SUPPLY
	INDIVIDUAL FLOOR DRAIN		WATER OUTLET
	PLUMBING FIXTURE		RADIATOR
	COVER		RECESSED CEILING
	RETURN VENT		ELECTRIC PANEL
	SUPPLY VENT		WATER METER
	SUPPLY VENT		BUTTON SWITCH
	RETURN VENT		DOOR
	RETURN VENT		GROUND-FAULT LIGHT
WOOD		FIRE PROTECTION	
	WOOD PANELING		FIRE EXTINGUISHER
	WOOD PANELING		FIRE PULL
	WOOD PANELING		FIRE ALARM HORN/SIREN
	WOOD PANELING		FIRE ALARM HORN/SIREN
	WOOD PANELING		SMOKE ALARM
	WOOD PANELING		FIRE ALARM HORN/SIREN
	WOOD PANELING		FIRE ALARM HORN/SIREN
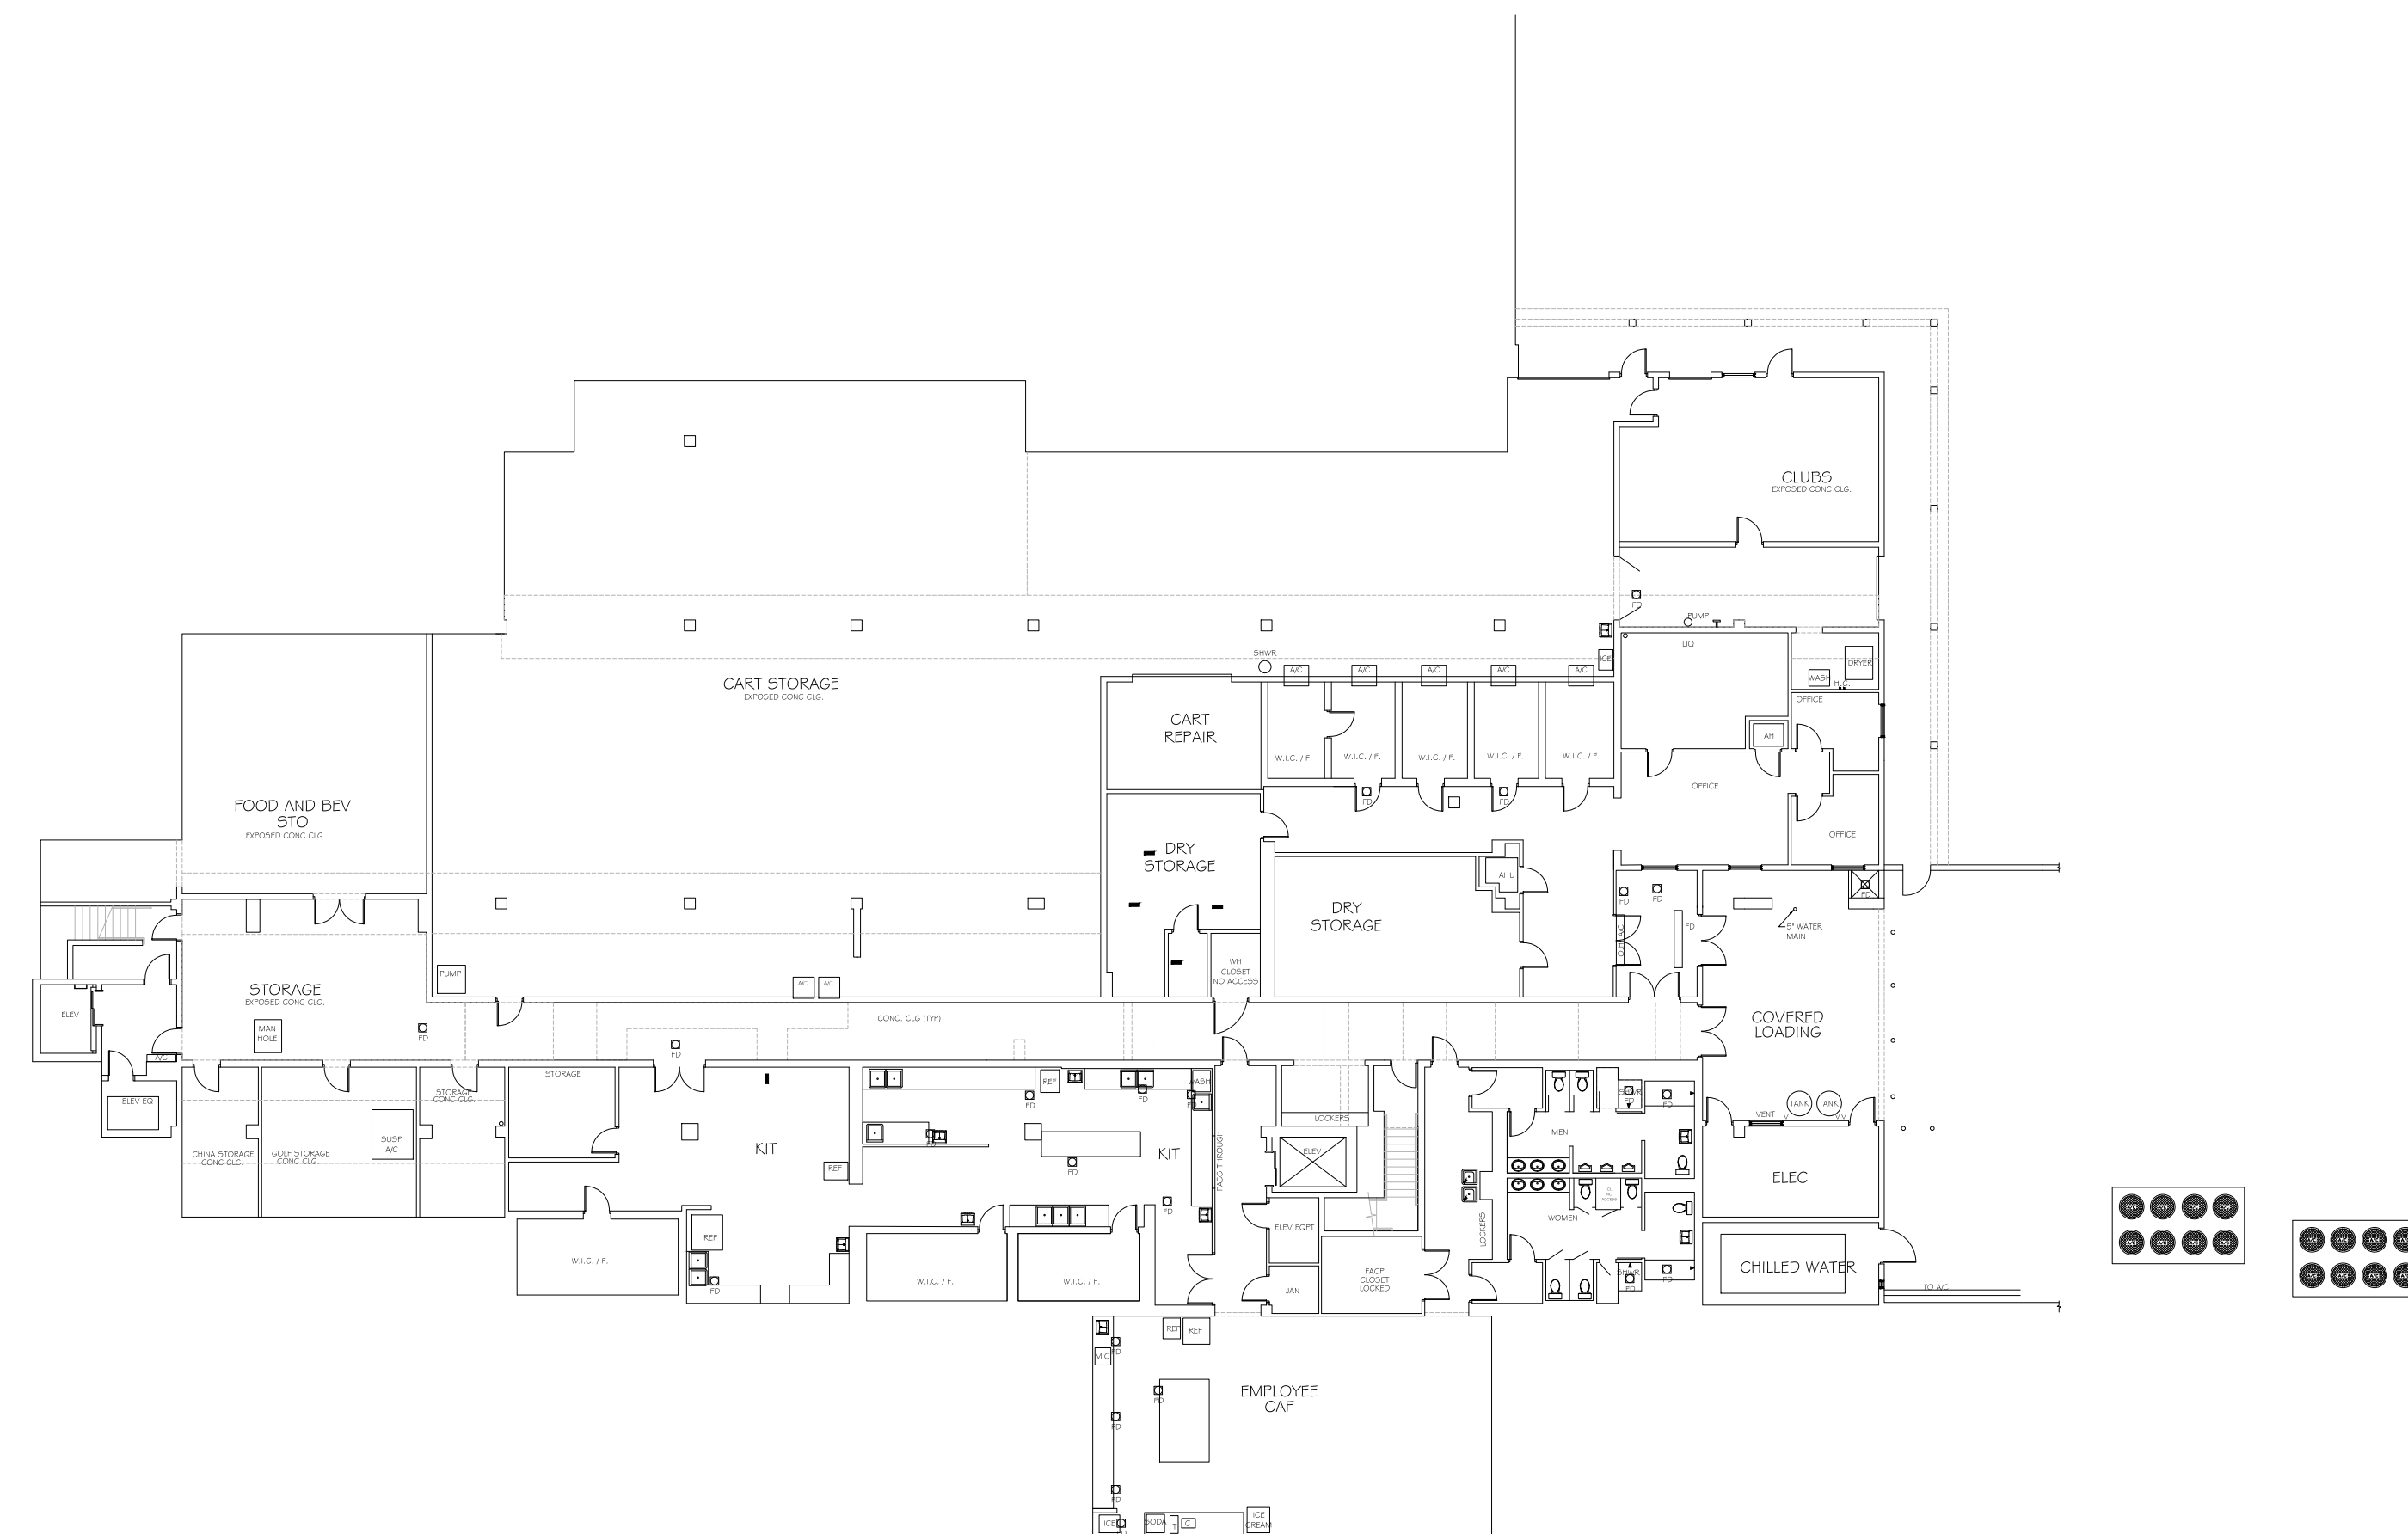

BASEMENT FLOOR PLAN
1/16" = 1'-0"

AS BUILT DOCUMENTATION: BALLENISLES COUNTRY CLUB

01		
NO.	ISSUES REVISIONS	DATE
		SHEET TITLE
Architectural Floor Plans Basement		
XX	PROJECT MANAGER	
HL	PROJECT DIRECTOR	
XX,XX,XX	PROJECT NUMBER	
AS NOTED	SCALE	
XX	DRAWN BY	
		SHEET NUMBER
XA201		

 
This architectural floor plan illustrates the layout of the first floor, which is divided into several functional zones. At the top, a 'COVERED SITTING (CANOPY)' area is shown. The left wing contains 'LADIES CARDS' (1, 2, 3), 'MENS CARDS', and 'MENS LOCKER' facilities. A central 'FOYER' and 'ENTRY' area serve as the main circulation hub. To the right of the foyer, there are 'OFFICE' spaces, 'STORAGE' rooms, and a 'BAR'. Further right, a large 'DINING' area is located. The bottom right section includes a 'MEETING' room, 'KIT' (kitchen), 'WASH', 'ELEV' (elevator), and 'STORAGE' spaces. The plan also shows various smaller rooms like 'PRO SHOP', 'DINING', 'OFFICE', 'STORAGE', 'KIT', 'WASH', 'ELEV', and 'STORAGE'. The building is accessed via a 'Porte-cochère' at the bottom.

FIRST FLOOR PLAN
1/16" = 1'-0"



Ks BUILT
PROFESSIONALS

A DIVISION OF:



AEC
CONSULTANTS INC

www.aecconsultantsinc.com

844.272.8458

© 2016 AEC CONSULTANTS INC

AS BUILT DOCUMENTATION: BALLENISLES COUNTRY CLUB

01		
NO.	ISSUES REVISIONS	DATE
		SHEET TITLE
Architectural Floor Plans Main Level		
XX		PROJECT MANAGER
HL		PROJECT DIRECTOR
XX.XX.XX		PROJECT NUMBER
AS NOTED		SCALE
XX		DRAWN BY
XA202		SHEET NUMBER

[illegible]

BASEMENT FLOOR PLAN
1/16" = 1'-0"

AS BUILT DOCUMENTATION: BALLENISLES COUNTRY CLUB

01		
NO.	ISSUES REVISIONS	DATE
		SHEET TITLE
Reflected Ceiling Plans (Basement)		
XX		PROJECT MANAGER
HL		PROJECT DIRECTOR
XX.XX.XX		PROJECT NUMBER
AS NOTED		SCALE
XX		DRAWN BY
		SHEET NUMBER

Reflected Ceiling Plans (Basement)

XX	PROJECT MANAGER
----	-----------------

HL	PROJECT DIRECTOR
----	------------------

XX.XX.XX	PROJECT NUMBER
----------	----------------

AS NOTED	SCALE
----------	-------

XX	DRAWN BY
----	----------

SHEET NUMBER

XA301

SYMBOLS LEGEND

RCP

Exhaust Vent

Ceiling Mounted Light Fixture

Recessed Can Light

Recessed Track Light

Recessed Linear Light

Recessed Linear Light with Diffuser

Camera

Meter Box

Supply Vent

Return Vent

Return Vent with Light

Exhaust Fan

Ceiling Fan

Ceiling Fan with Light

7-2-6 Sign

Sprinkler

ELECTRIC

Data Outlet

Telephone Jack

Electric Switch

Electric Receptacle

Electric Receptacle with Grounding Pin

Electric Receptacle with Grounding Pin and GFI

Electric Panel

Electric Meter

Button Switch

Smoke Detector

Ground/Floor Light

FIRE PROTECTION

Fire Extinguisher

Fire Pull

Fire Alarm Horn/Notifier

Smoke Detector

Emergency Head


MEP

Thermostat

Floor Drain

Valve

Access Box

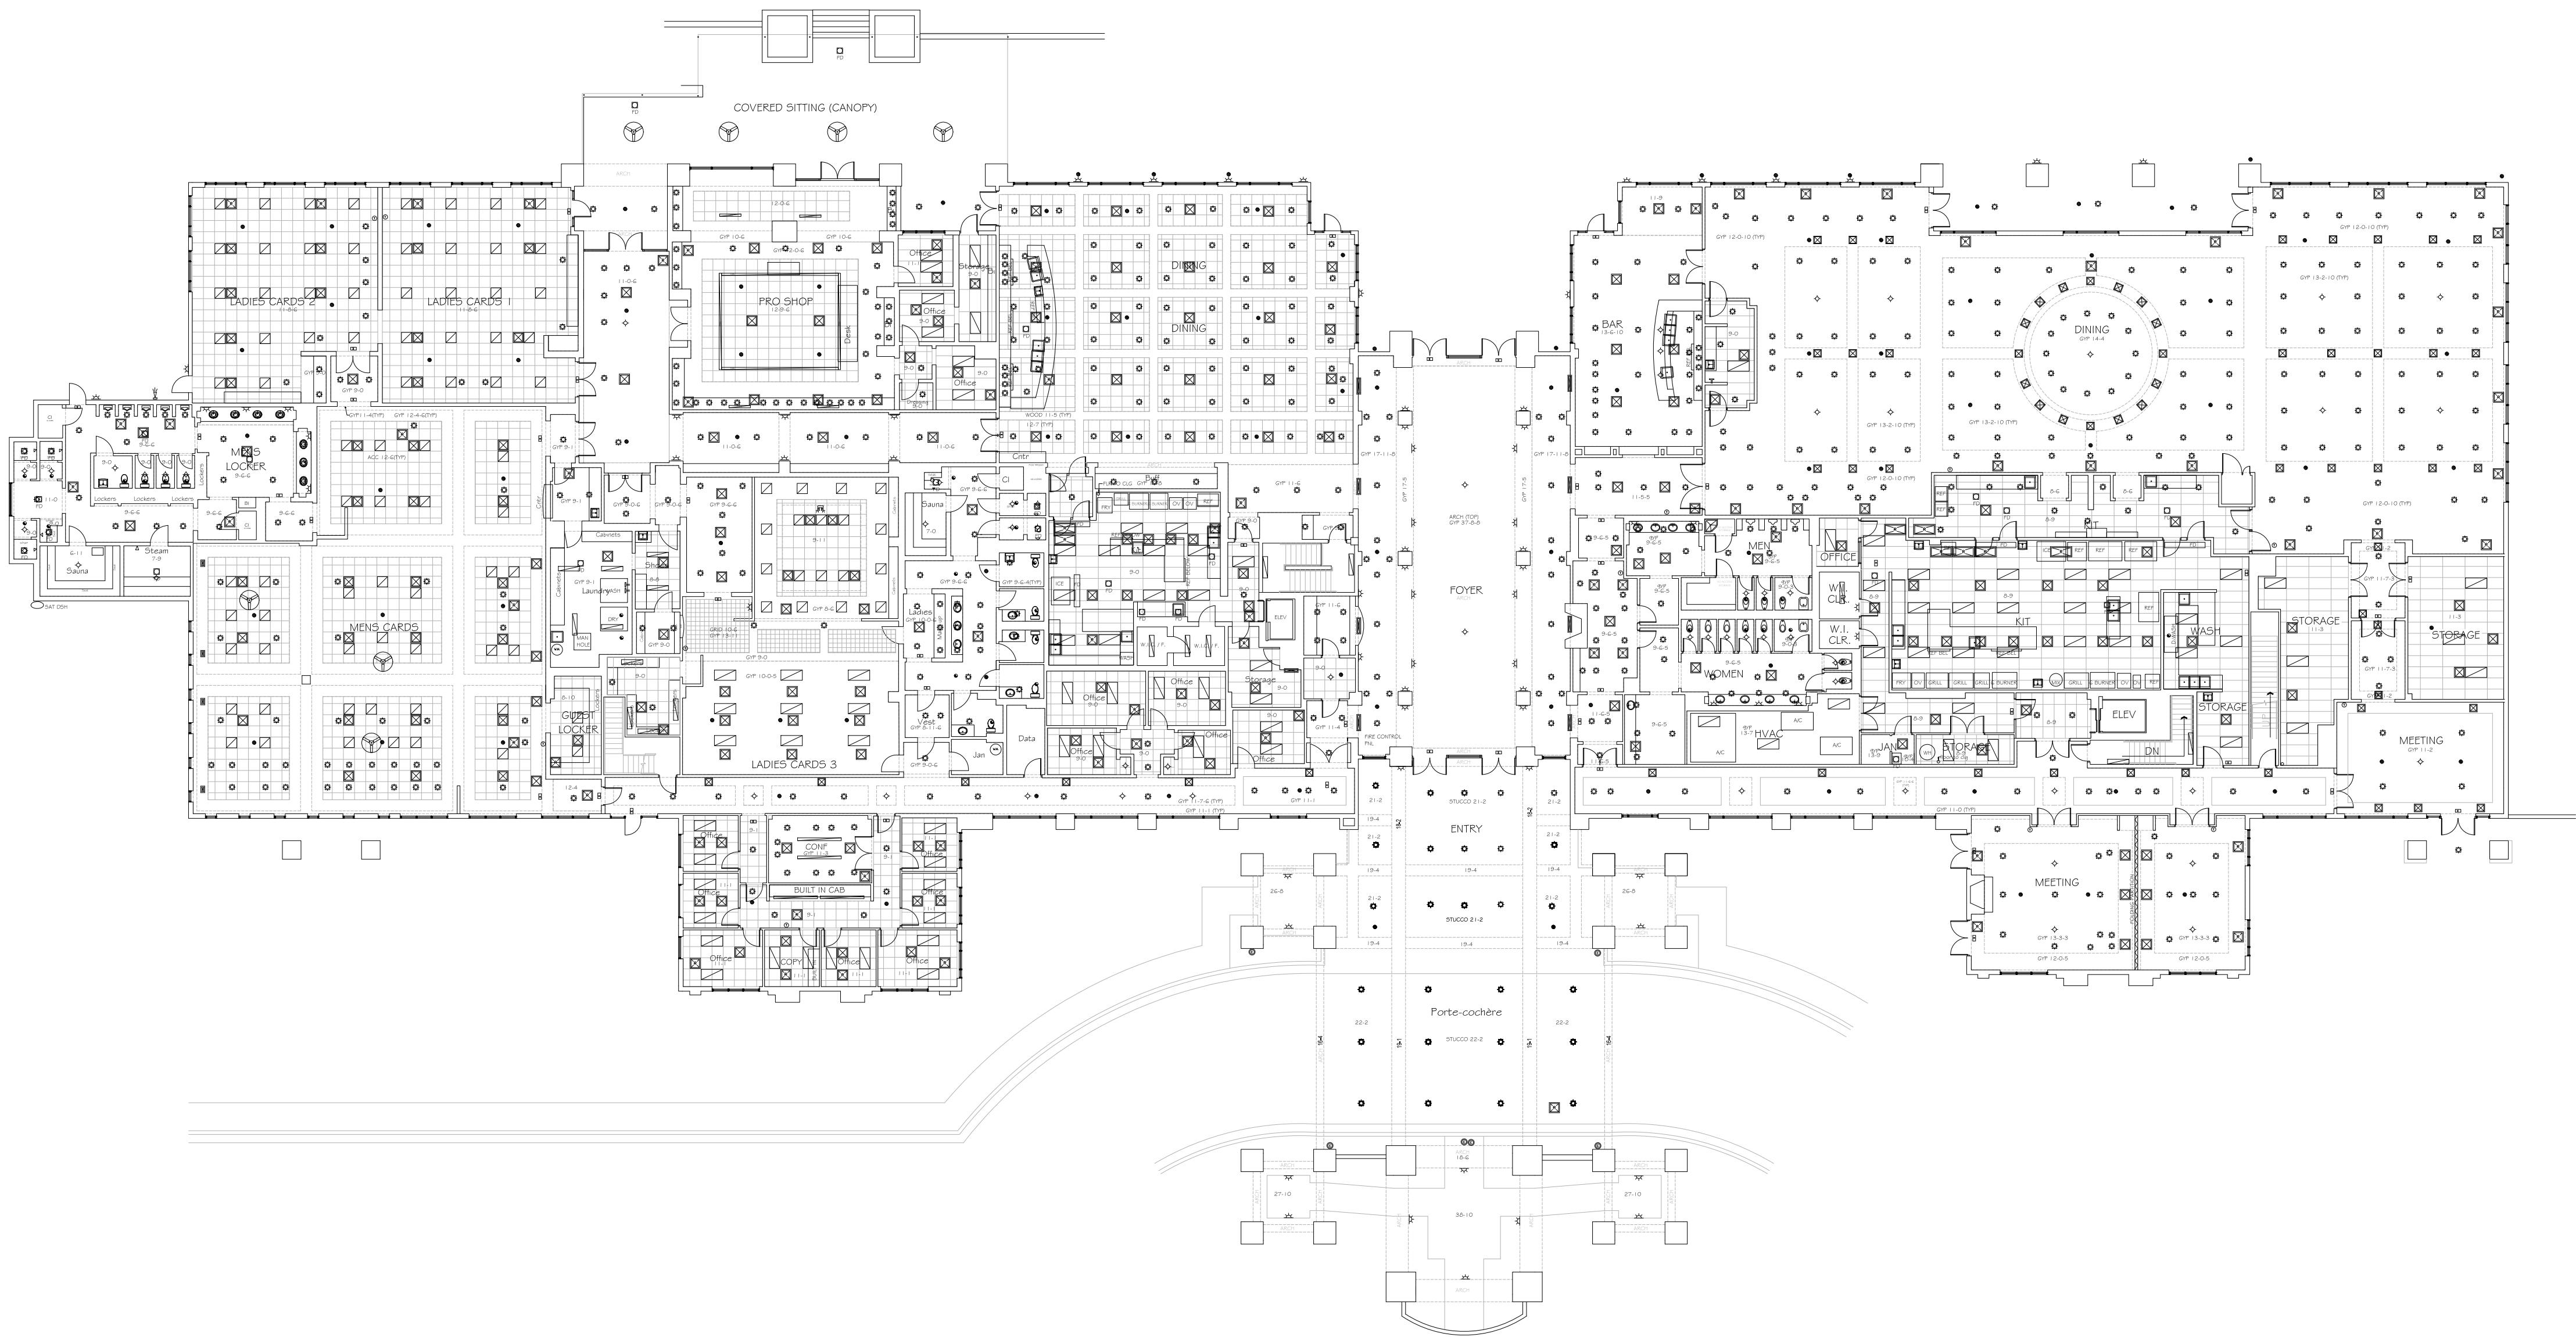

FIRST FLOOR PLAN
1/16"= 1'-0"

Ks BUILT
PROFESSIONALS

A DIVISION OF:



© 2016 AEC CONSULTANTS INC.

AS BUILT DOCUMENTATION: BALLENISLES COUNTRY CLUB


Reflected Ceiling
Plans (Main Level)


XX	PROJECT MANAGER
HL	PROJECT DIRECTOR
XX.XX.XX	PROJECT NUMBER
AS NOTED	SCALE
XX	DRAWN BY
	SHEET NUMBER

XA302

[illegible]

XA401

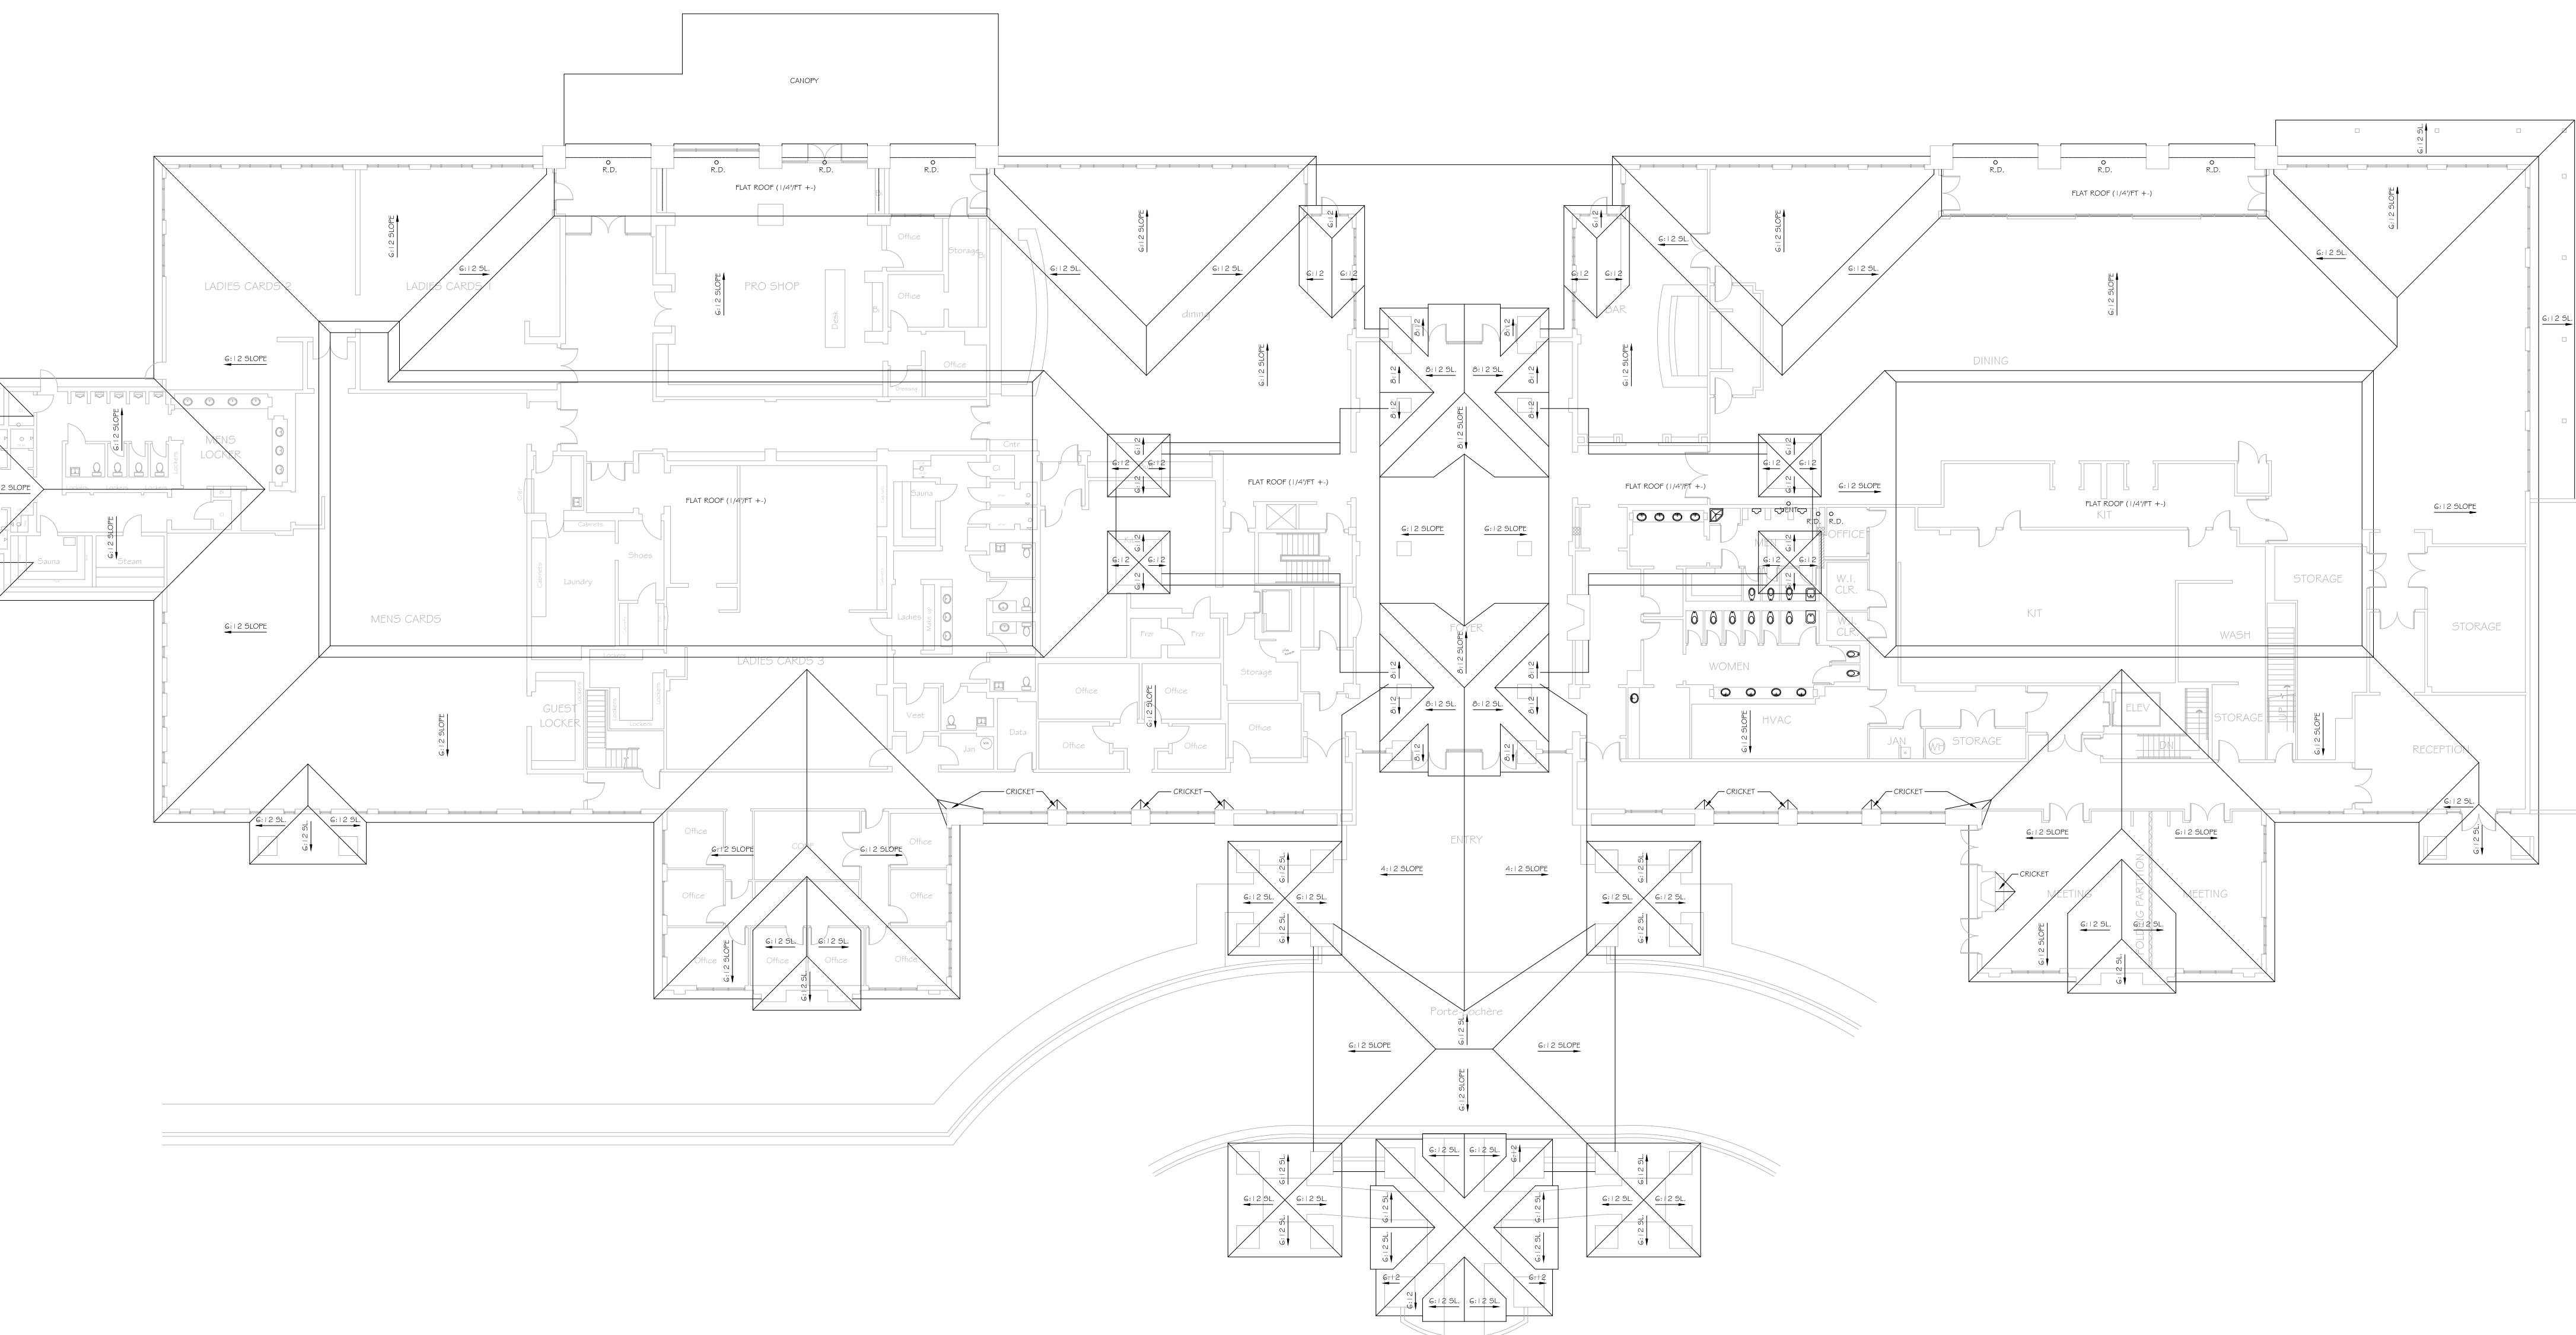

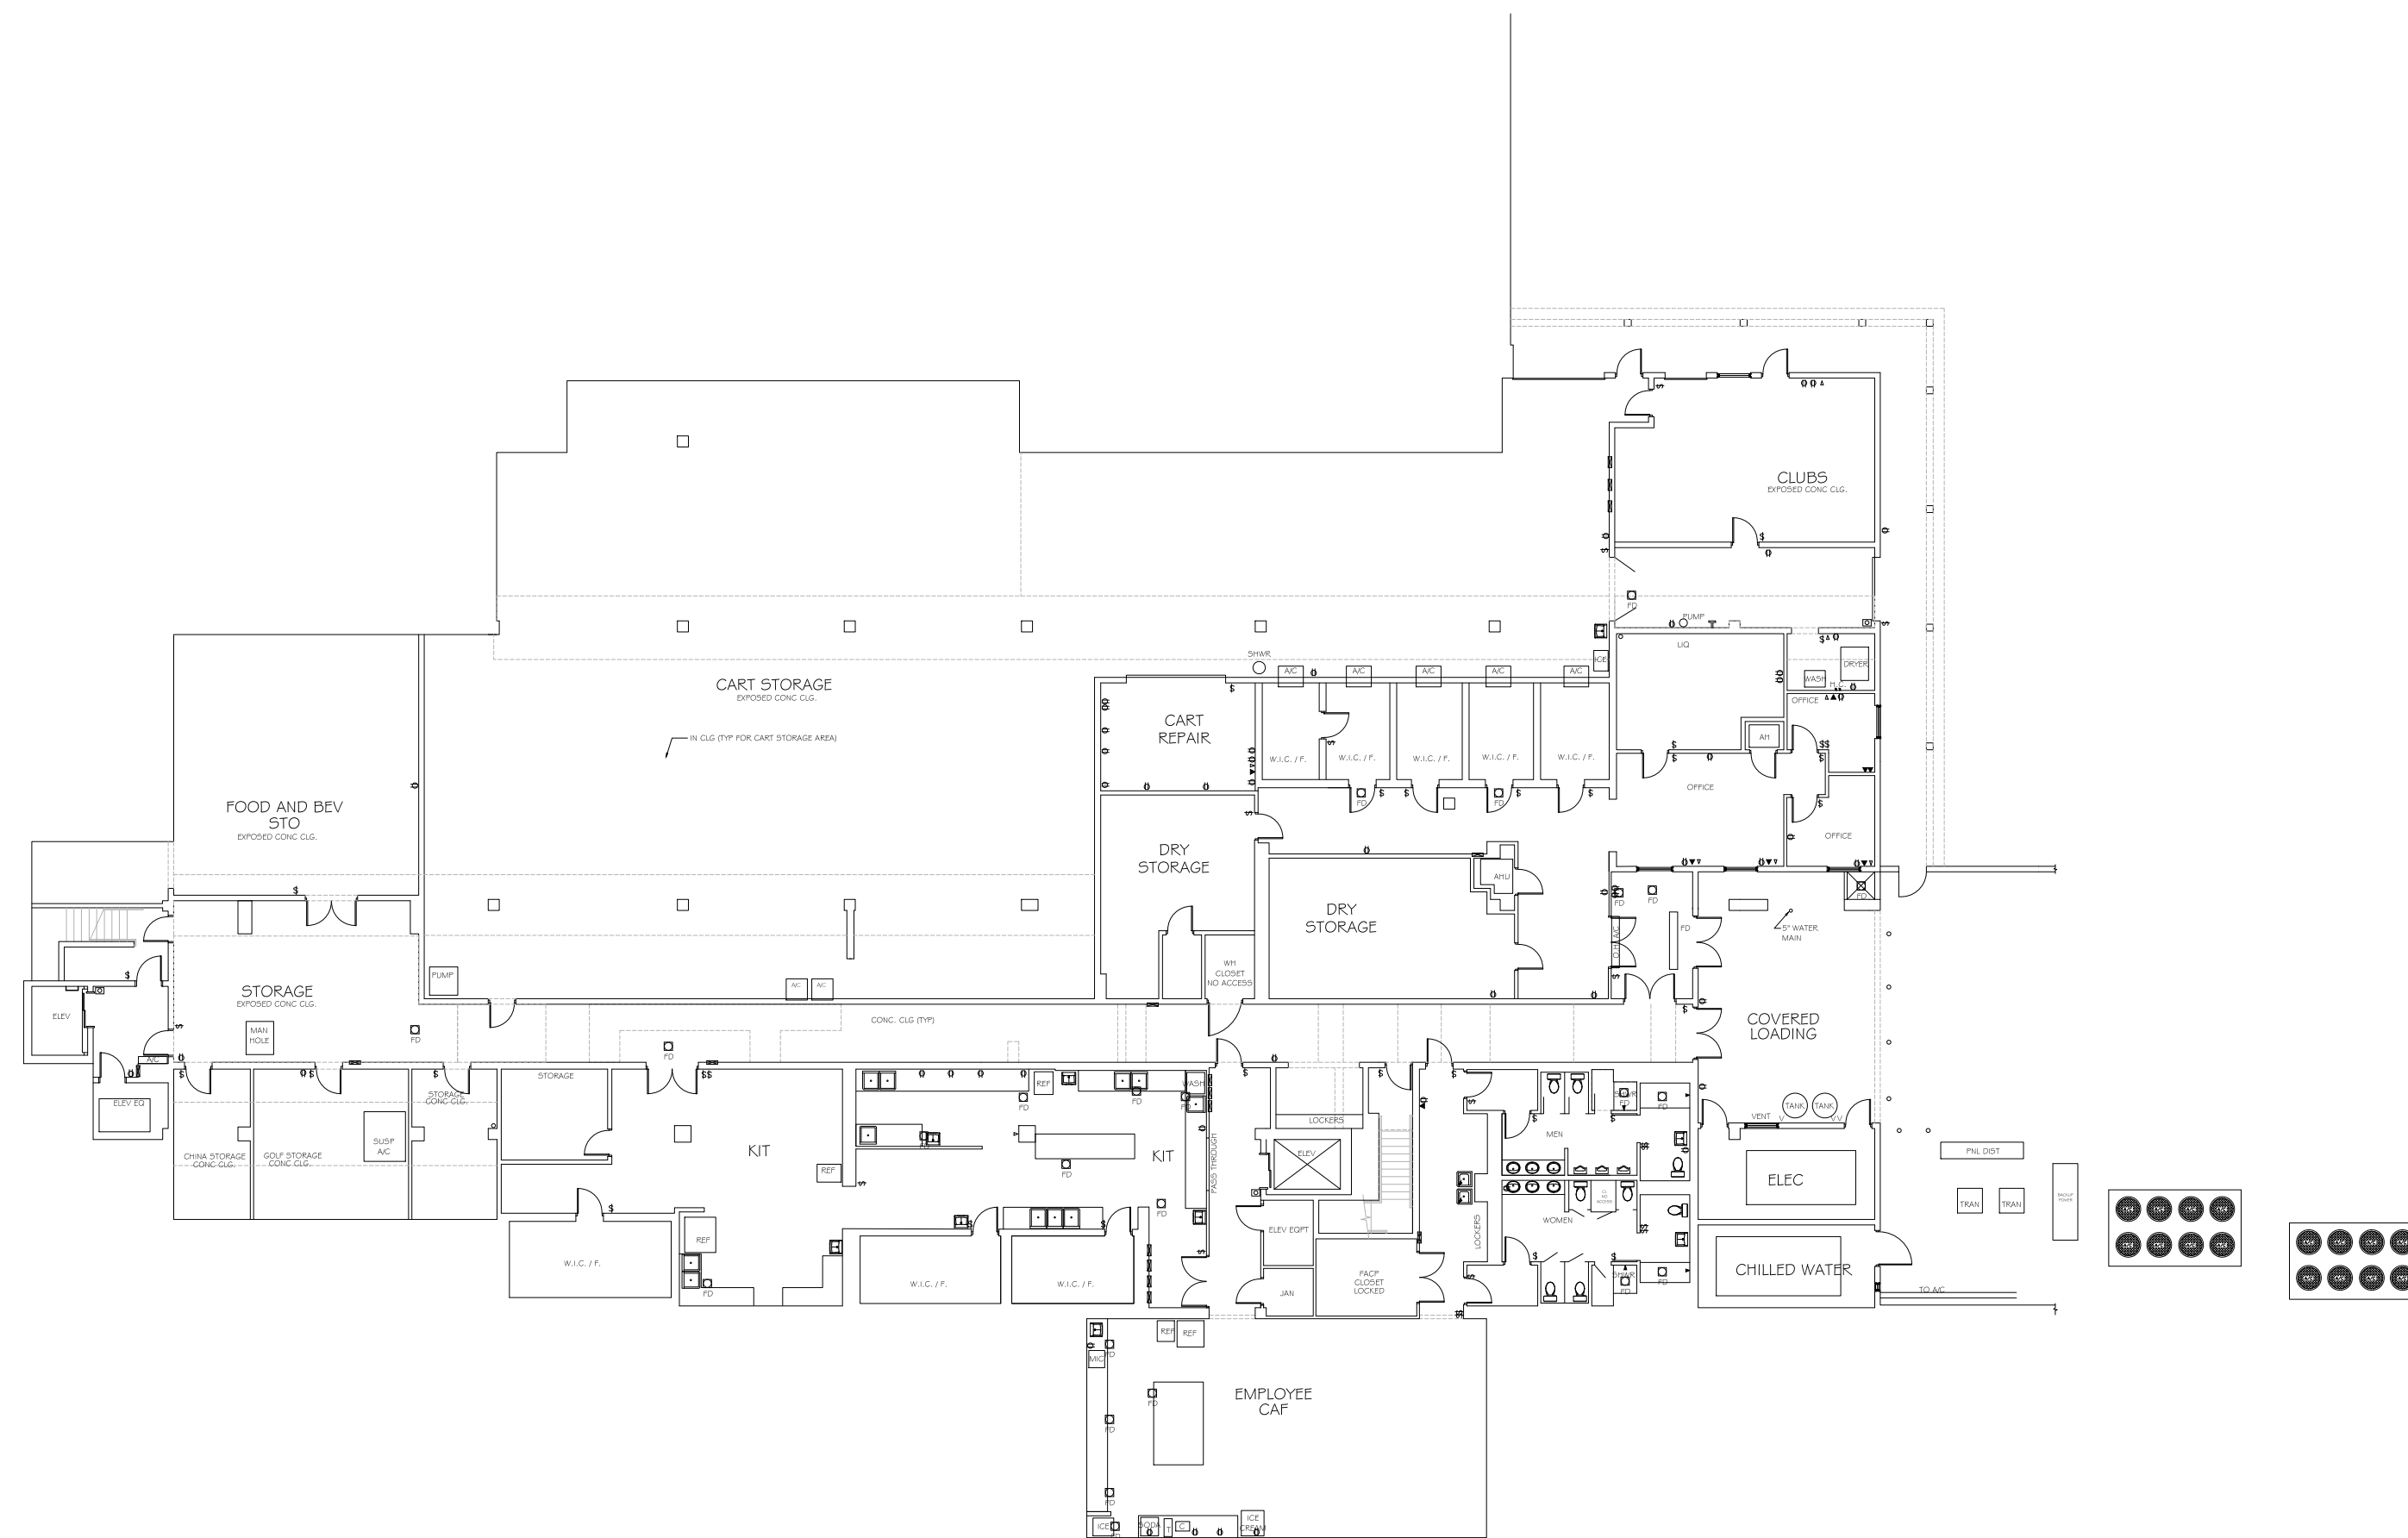[illegible]

BASEMENT FLOOR PLAN
1/16" = 1'-0"



Ks BUILT 
PROFESSIONALS

A DIVISION OF:

AEC

— ■ —

CONSULTANTS INC


www.aecconsultantsinc.com

844.272.8458

© 2016 AEC CONSULTANTS INC.

AS BUILT DOCUMENTATION: BALLENISLES COUNTRY CLUB

01		
NO.	ISSUES REVISIONS	DATE
		SHEET TITLE
Electrical Plans (Basement)		
XX		PROJECT MANAGER
HL		PROJECT DIRECTOR
XX.XX.XX		PROJECT NUMBER
AS NOTED		SCALE
XX		DRAWN BY
		SHEET NUMBER
XE201		

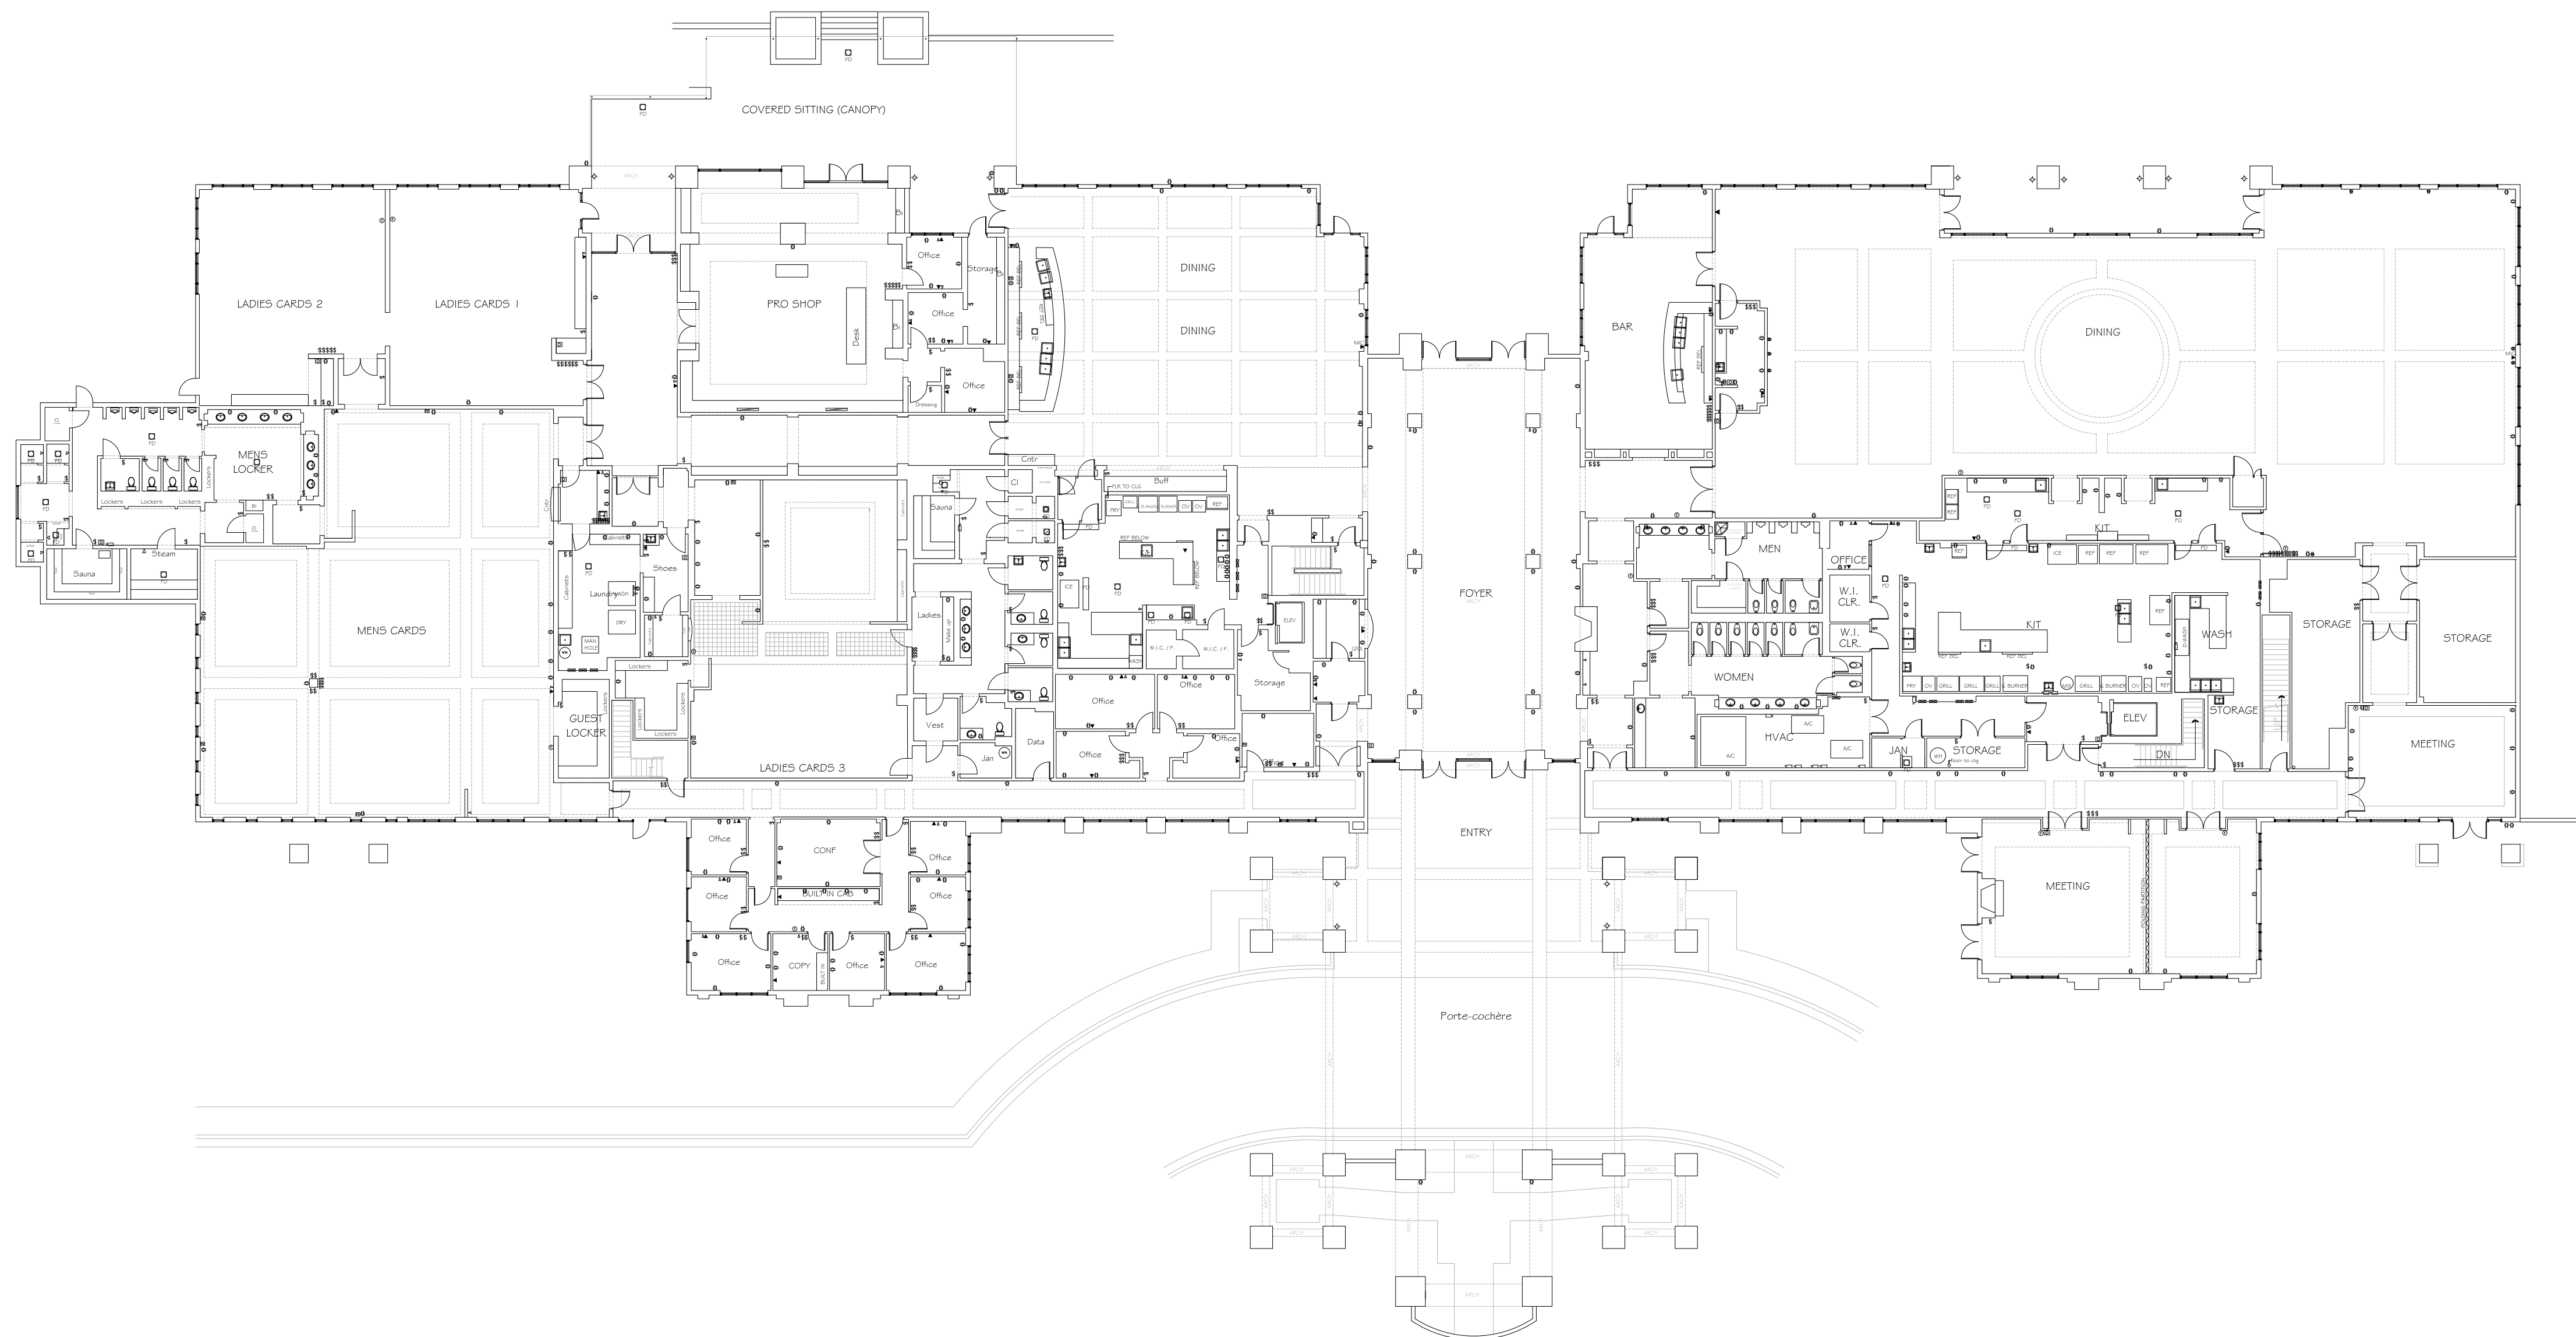
[illegible]

FIRST FLOOR PLAN
1/16" = 1'-0"

AS BUILT DOCUMENTATION: BALLENISLES COUNTRY CLUB


01			
NO.	ISSUES REVISIONS	DATE	
SHEET TITLE			
Electrical Plans (Main Level)			
XX		PROJECT MANAGER	
H/L		PROJECT DIRECTOR	
XX.XX.XX		PROJECT NUMBER	
A/S NOTED		SCALE	
XX		DRAWN BY	
		SHEET NUMBER	
XE202			

RCP		ELECTRIC	
	COMMON VENT		DATA OUTLET
	COMMON VENT		TELEPHONE JACK
	COMMON VENT		ELECTRIC METER
	NECESSARY FOR LIGHT		TELEVISION
	INDUSTRIAL FLOOR		PLUMBING
	INDUSTRIAL FLOOR		STEEL PAPER
	INDUSTRIAL FLOOR		STEEL PAPER
	INDUSTRIAL FLOOR		STEEL PAPER
	COMMON		STEEL PAPER
	METHOD SET		STEEL PAPER
	SUPPLY VENT		ELECTRIC PUMP
	SUPPLY VENT		ELECTRIC PUMP
	RETURN VENT		BUTTON SWITCH
	RETURN VENT		FLUORIDE
	RETURN VENT		GROUND-FLOOR LIGHT
	RETURN VENT		
	RETURN VENT		
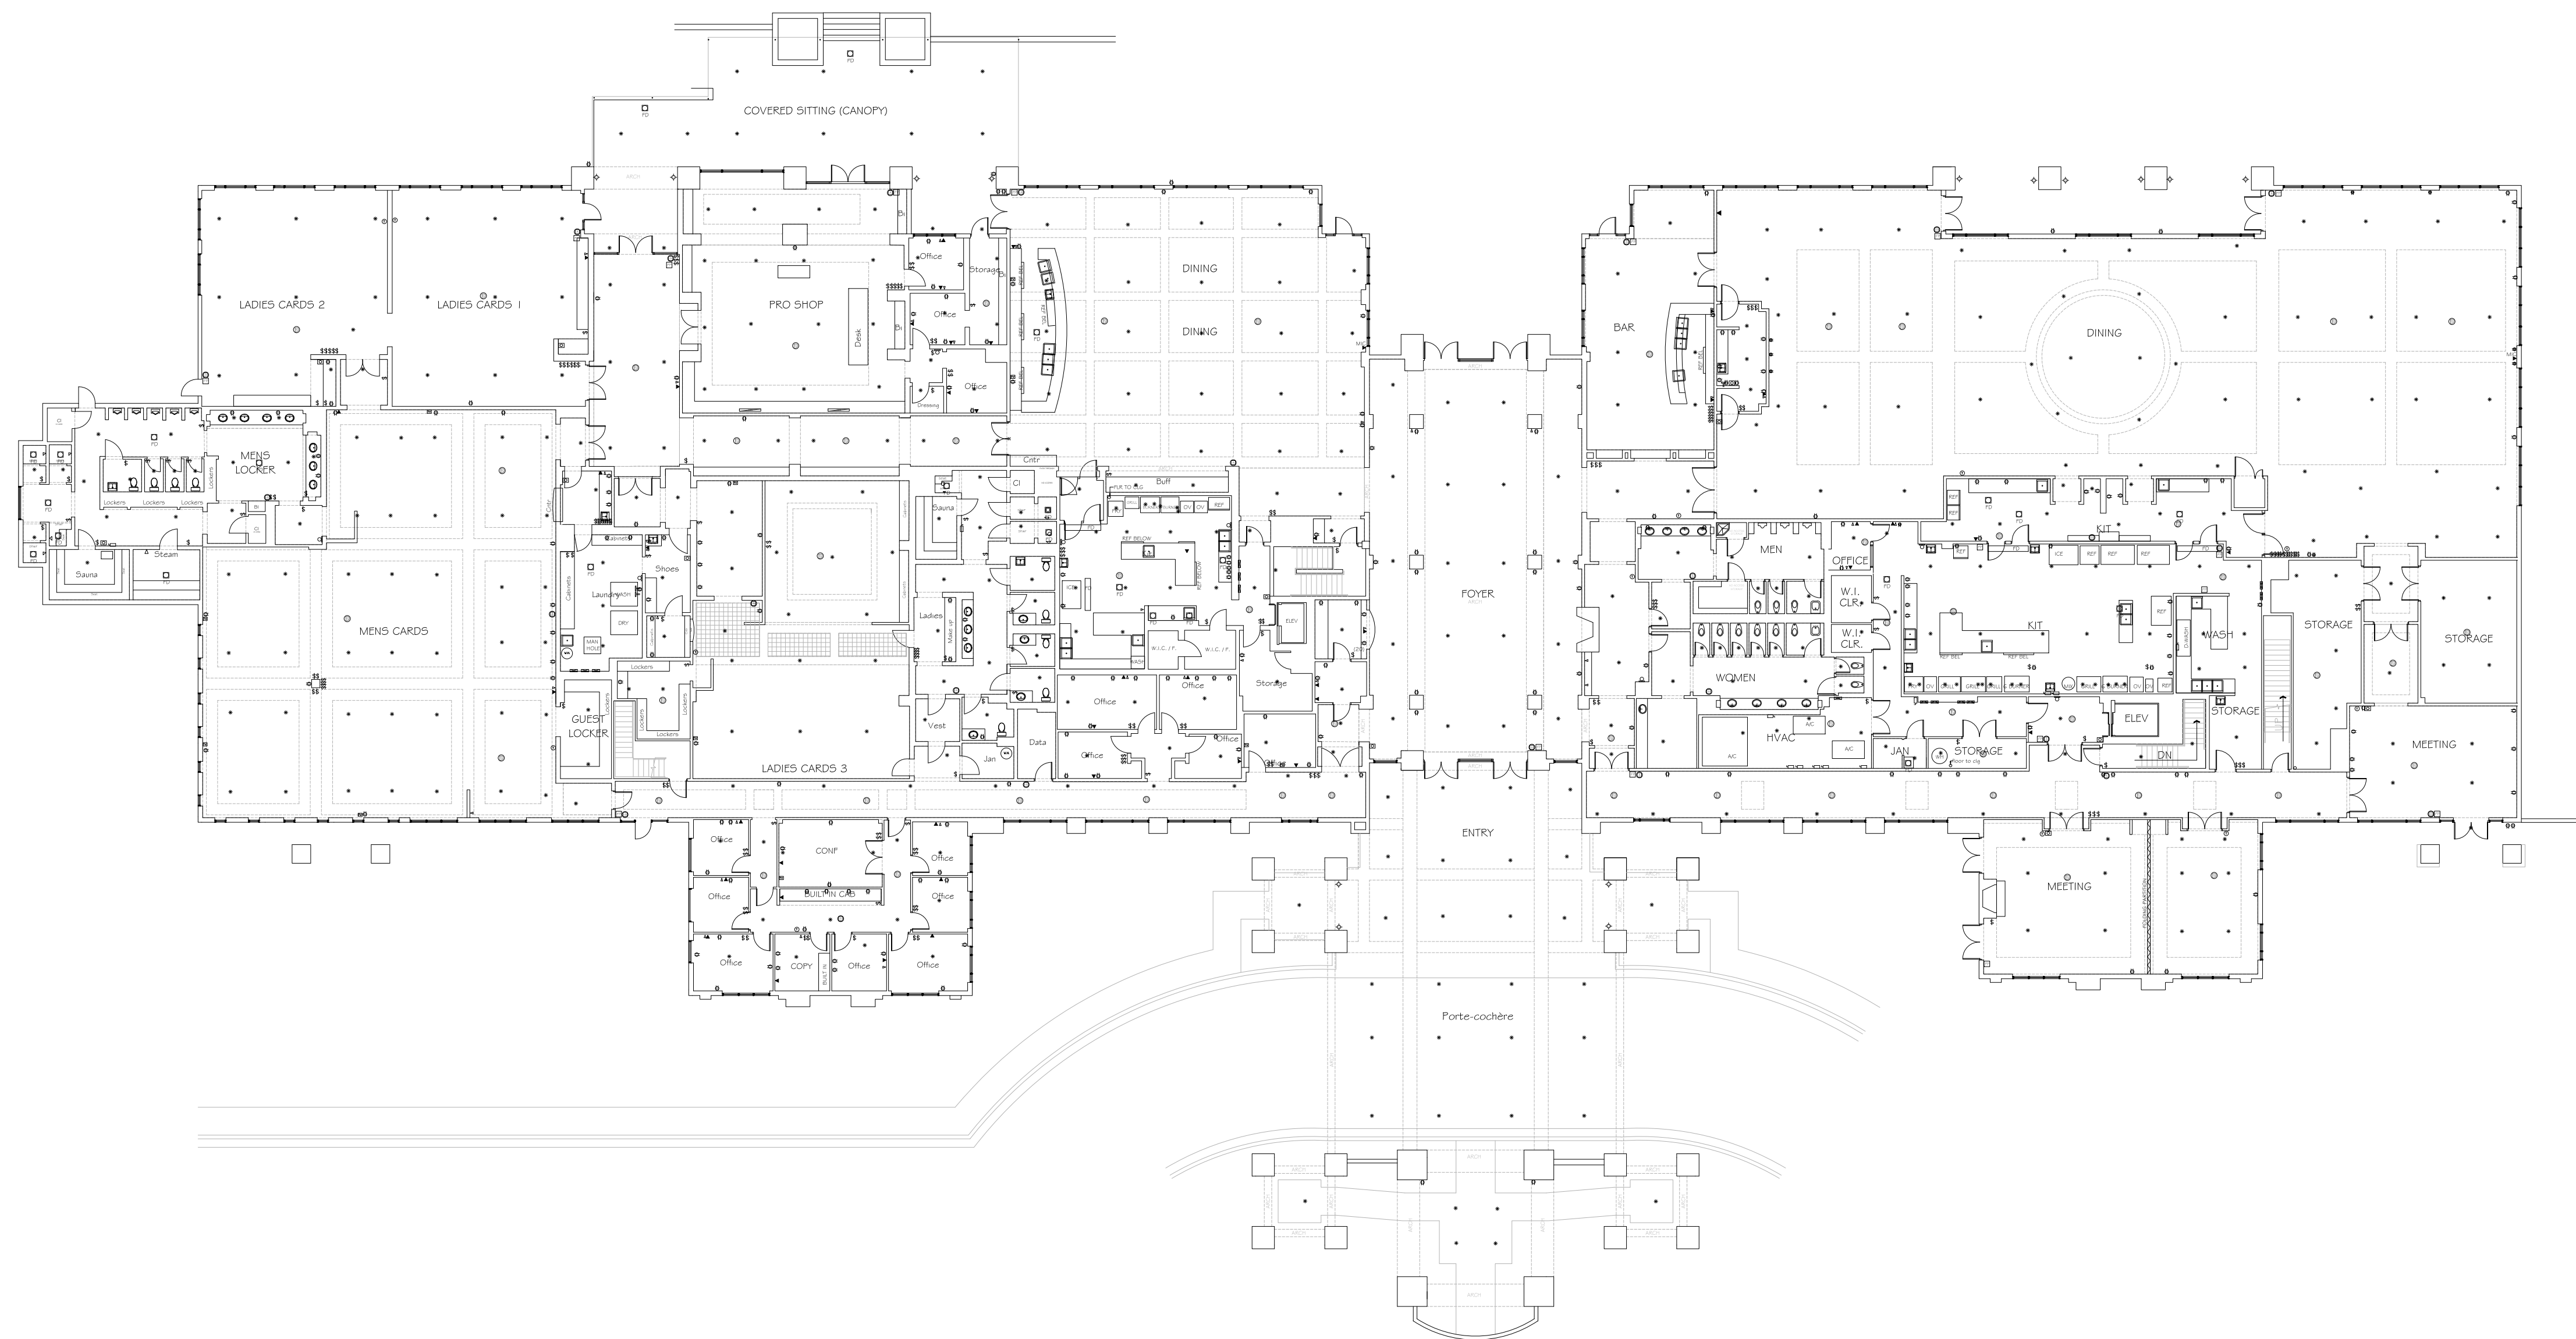

FIRST FLOOR PLAN
1/16" = 1'-0"

01		
NO.	ISSUES REVISIONS	DATE
		SHEET TITLE
Fire Protection Plans (Main Level)		
XX	PROJECT MANAGER	
HL	PROJECT DIRECTOR	
XX.XX.XX	PROJECT NUMBER	
AS NOTED	SCALE	
XX	DRAWN BY	
		SHEET NUMBER
XFP002		

 SECTION
$$1/16'' = 1'-0''$$

AS BUILT DOCUMENTATION: BALLENISLES COUNTRY CLUB

Mechanical / Plumbing /Equipment Plans (Main Level)

XM202

