

AS-BUILT DOCUMENTATION

SUNRISE MOUNTAIN PLAZA


LAS VEGAS, NV 89110



100% SUBMITTAL

DRAWING INDEX

- C-1 COVER SHEET | DRAWING INDEX
- SL SYMBOLS LEGEND
- AB-1 KEY PLAN
- AB-2 GROUND FLOOR PLAN
- AB-3 ENLARGED FLOOR PLAN
- AB-4 ENLARGED FLOOR PLAN
- AB-5 ENLARGED FLOOR PLAN
- AB-6 ENLARGED FLOOR PLAN
- AB-7 ENLARGED FLOOR PLAN
- AB-8 ENLARGED FLOOR PLAN
- AB-9 MEZZANINE PLAN
- AB-10 EXTERIOR ELEVATIONS
- AB-11 EXTERIOR ELEVATIONS
- AB-12 EXTERIOR ELEVATIONS
- AB-13 EXTERIOR ELEVATIONS
- AB-14 EXTERIOR ELEVATIONS

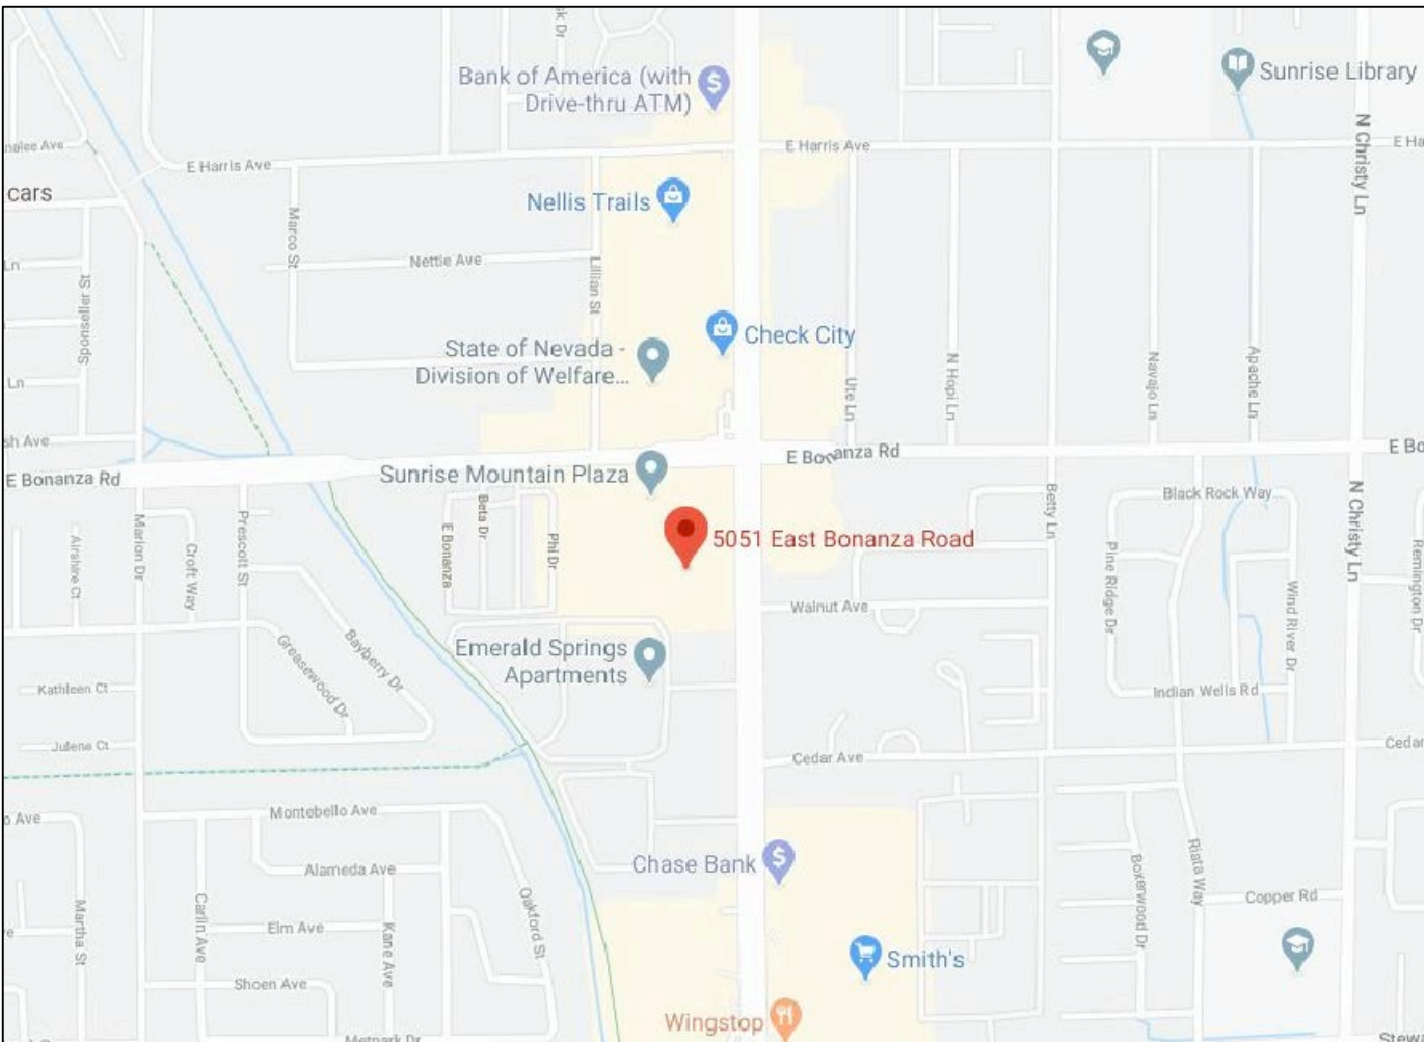

VICINITY MAP NTS

AREA DATA	
KMART GROUND FLOOR	97,344 S.F. ±
KMART MEZZANINE	13,156 S.F. ±
KMART GARDEN CENTER	6,506 S.F. ±
TOTAL KMART	117,006 S.F. ±

AS BUILT

PROFESSIONALS

www.asbuiltprofessionals.com

A DIVISION OF:

AEC

CONSULTANTS INC

844.272.8458

844 AS BUILT

© 2020 AEC CONSULTANTS INC

ARCHITECTURAL AS BUILT

SUNRISE MOUNTAIN PLAZA

LAS VEGAS, NV 89110

O1	100% SUBMISSION	
NO.	ISSUES REVISIONS	DATE
		SHEET TITLE
COVER SHEET		
HL	PROJECT MANAGER	
HL	PROJECT DIRECTOR	
	PROJECT NUMBER	
	SCALE	
MM	DRAWN BY	
		SHEET NUMBER
C-1		

SYMBOLS LEGEND

RCP

	EXHAUST VENT		TRACK LIGHT OR VANITY LIGHT
	CEILING MOUNTED LIGHT FIXTURE		WALL-MOUNTED LIGHT FIXTURE
	CEILING MOUNTED DIRECTIONAL LIGHT		EMERGENCY EXIT SIGN
	RECESSED CAN LIGHT		EMERGENCY EXIT LIGHT
	EYEBALL OR SMALL CAN LIGHT		EMERGENCY EXIT LIGHT W/ SIGN
	PENDANT LIGHT		LIGHTED STAIR SIGN
	INDIVIDUAL FLUOR. LAY-IN FIXTURE 4 BULB		FLOOD LIGHT
	INDIVIDUAL FLUOR. HANGING FIXTURE 2 BULB		PHOTO CELL
	INDIVIDUAL FLUOR. FLUSH MOUNT FIXTURE 4 BULB		CEILING FAN
	CAMERA		CEILING FAN W/ LIGHT KIT
	MOTION DET.		7-2-6 CEILING HEIGHT AND TRIM 7'-2" ABOVE FLOOR BELOW WITH 6" CROWN MOULDING. NOTE: ALL CEILINGS NOT LABELED ARE PLASTER. CEILINGS SHOWN WITH A GRID ARE LAY IN ACOUSTICAL TILE..
	SUPPLY VENT		JUNCTION BOX
	SUPPLY VENT		
	RETURN VENT		
	RETURN VENT		
	SPEAKER		

ELECTRIC

	DATA OUTLET
	TELEPHONE JACK
	ELECTRIC SWITCH
	CABLE TELEVISION OUTLET
	DUPLEX RECEPTACLE OUTLET
	SPECIAL PURPOSE CONNECTION OR OUTLET
	QUADRUPLIX RECEPTACLE OUTLET
	FLOOR DUPLEX RECEPTACLE OUTLET
	ELECTRIC PANEL
	ELECTRIC METER
	BUTTON SWITCH
	DISCONNECT SWITCH
	GROUND/FLOOR LIGHT
	KEY PAD

FIRE PROTECTION


	FIRE EXTINGUISHER
	FIRE PULL
	FIRE ALARM (HORN/SRTOBE)
	SMOKE DETECTOR
	SMOKE ALARM SPEAKER
	SPRINKLER HEAD CEILING MOUNT
	SPRINKLER HEAD WALL MOUNT

MEP


	THERMOSTAT
	FLOOR DRAIN
	VALVE
	HOSE BIB
	WATER SUPPLY
	SUSPENDED GAS HEATER

MISC

	BOLLARD
	SPOT ELEVATION

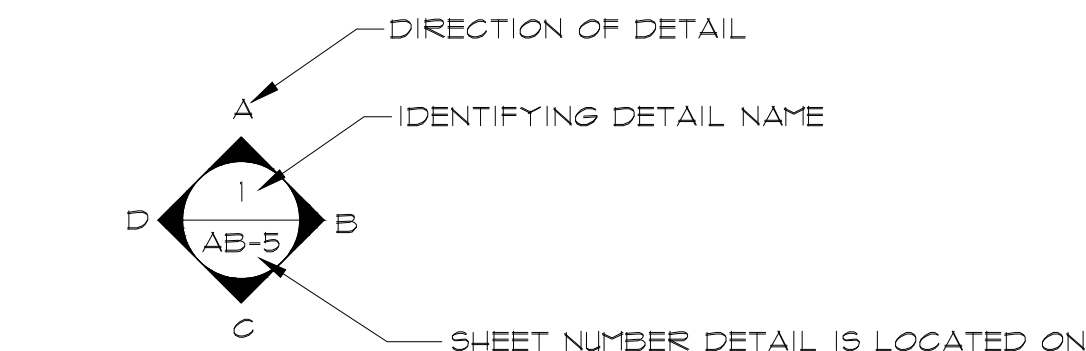

INTERIOR ELEVATIONS

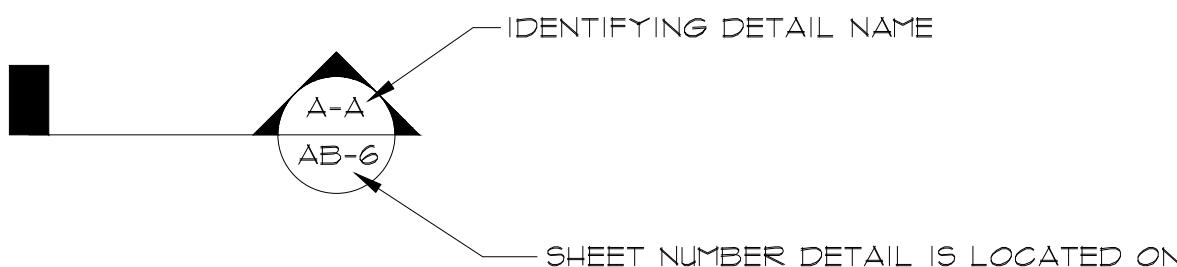

BUILDING SECTION

PHOTO DOCUMENTATION LEGEND

INDICATES LOCATION OF CAMERA

INDICATES DIRECTION OF CAMERA LENS AND CORRESPONDING PHOTO / VIDEO NUMBER

TYPES OF DOCUMENTATION

GROUND BASED PHOTO 001

GROUND BASED VIDEO V-001

360° SPHERICAL PHOTO 123

AERIAL BASED PHOTO 000

AERIAL BASED VIDEO V-000

As BUILT PROFESSIONALS

www.asbuiltprofessionals.com

A DIVISION OF:

AEC CONSULTANTS INC

844.272.8458

844 AS BUILT

© 2020 AEC CONSULTANTS INC












ARCHITECTURAL AS BUILT

SUNRISE MOUNTAIN PLAZA

LAS VEGAS, NV 89110

01	100% SUBMISSION	
NO.	ISSUES REVISIONS	DATE
		SHEET TITLE
HL		PROJECT MANAGER
HL		PROJECT DIRECTOR
		PROJECT NUMBER
		SCALE
MM		DRAWN BY
		SHEET NUMBER

  SL

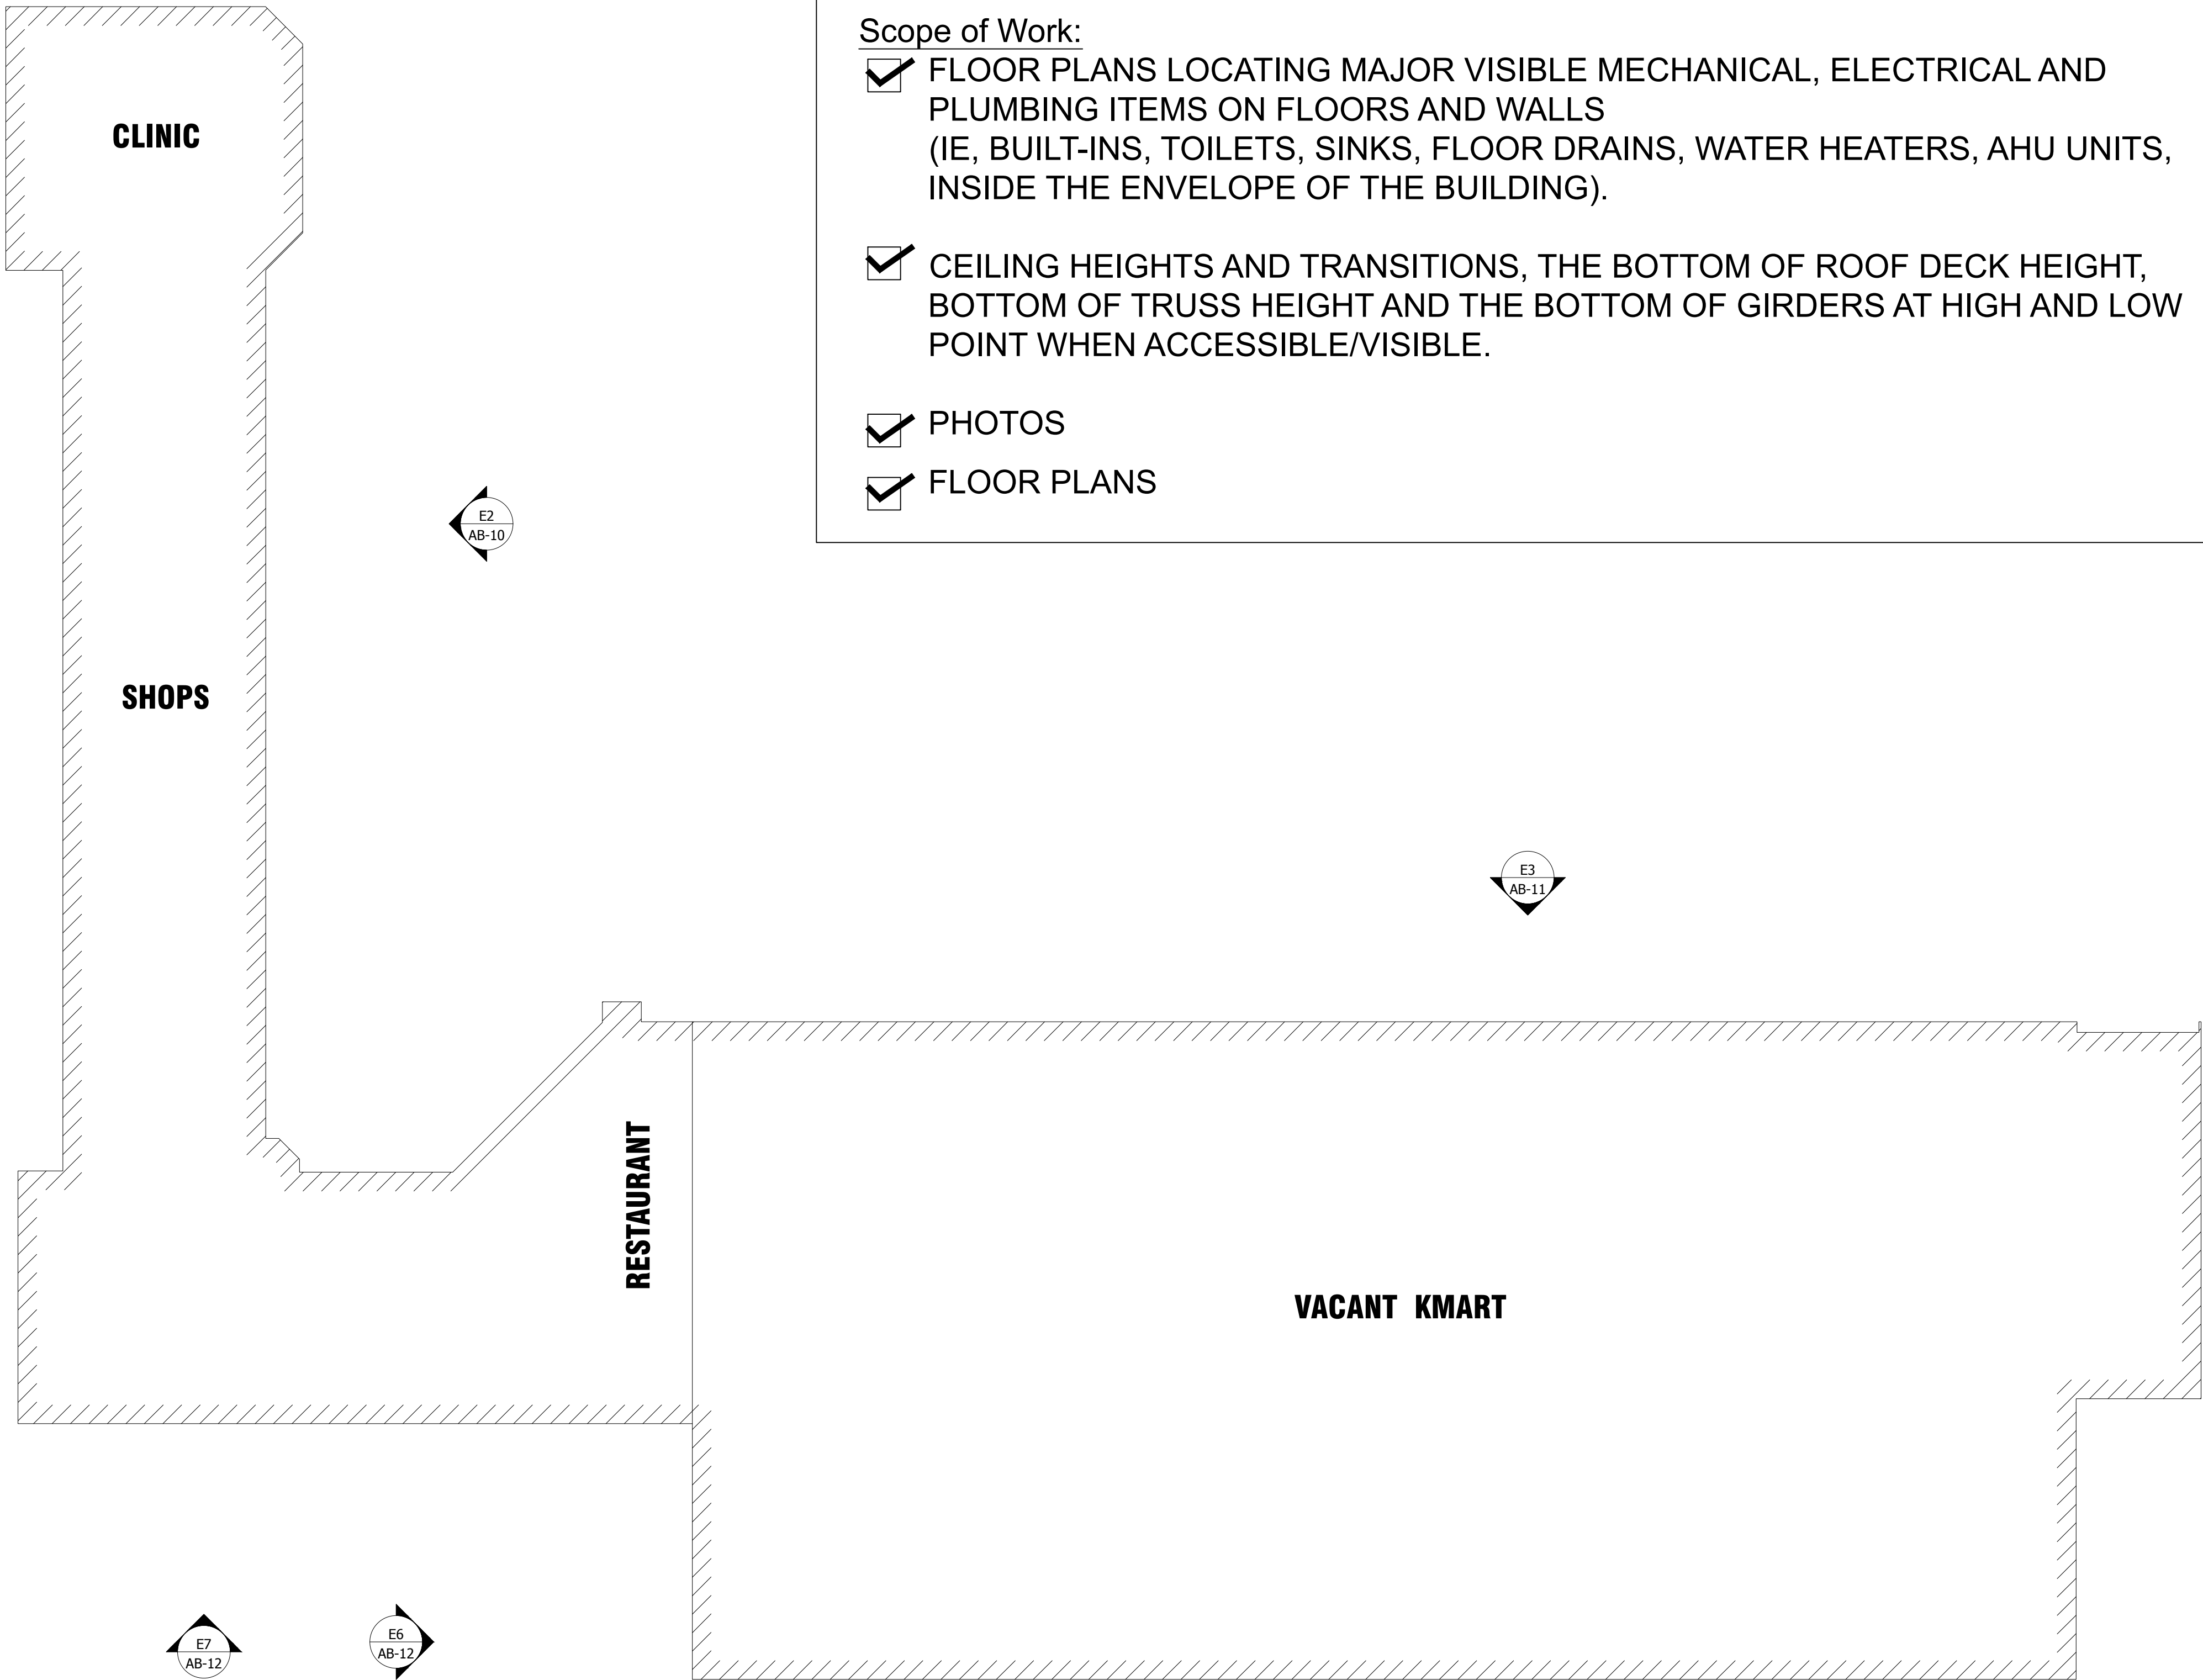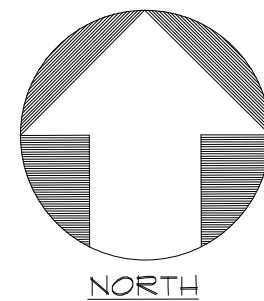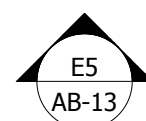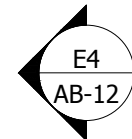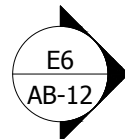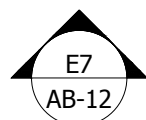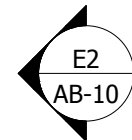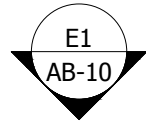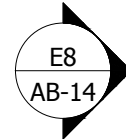

KEY PLAN
NTS

Scope of Work:

- ☒ FLOOR PLANS LOCATING MAJOR VISIBLE MECHANICAL, ELECTRICAL AND PLUMBING ITEMS ON FLOORS AND WALLS (IE, BUILT-INS, TOILETS, SINKS, FLOOR DRAINS, WATER HEATERS, AHU UNITS, INSIDE THE ENVELOPE OF THE BUILDING).
- ☒ CEILING HEIGHTS AND TRANSITIONS, THE BOTTOM OF ROOF DECK HEIGHT, BOTTOM OF TRUSS HEIGHT AND THE BOTTOM OF GIRDERS AT HIGH AND LOW POINT WHEN ACCESSIBLE/VISIBLE.
- ☒ PHOTOS
- ☒ FLOOR PLANS

As BUILT

PROFESSIONALS

www.asbuiltprofessionals.com

A DIVISION OF:

AEC

CONSULTANTS INC

844.272.8458



844 AS BUILT

© 2020 AEC CONSULTANTS INC

ARCHITECTURAL AS BUILT
SUNRISE MOUNTAIN PLAZA
LAS VEGAS, NV 89110


01		100% SUBMISSION		
NO.	ISSUES REVISIONS			DATE
SHEET TITLE				
KEY PLAN				
HL	PROJECT MANAGER			
HL	PROJECT DIRECTOR			
	PROJECT NUMBER			
NTS	SCALE			
MM	DRAWN BY			
SHEET NUMBER				
AB-1				

AREA DATA					
STORAGE 1	1,078 ±				
CORRIDOR 1	351 ±				
CLOSET 1	63 ±				
STOR 3 / LOADING DOCK	4,571 ±				
WASTE	195 ±				
COMM	88 ±				
DATA	62 ±				
ELEC	113 ±				
UTILITY	430 ±				
STORAGE 4	402 ±				
STORAGE 5	267 ±				
STORAGE 6	751 ±				
LAWWAY	364 ±				
OFFICE 4	371 ±				
LADIES ROOM	262 ±				
MENS ROOM	116 ±				
MENS ROOM 2	231 ±				
CORRIDOR 2	290 ±				
CORRIDOR 3	408 ±				
CORRIDOR 4	121 ±				
STORAGE 8	322 ±				
BREAKROOM	323 ±				
KITCHEN	166 ±				
MAIL ROOM	216 ±				
OFFICE 3	98 ±				
FIRE RISER	113 ±				
PHARMACY	471 ±				
PHARMACY BATHROOM	63 ±				
DRESSING ROOMS	910 ±				
SALES FLOOR	84,126 ±				
TOTAL	97344 ±				

 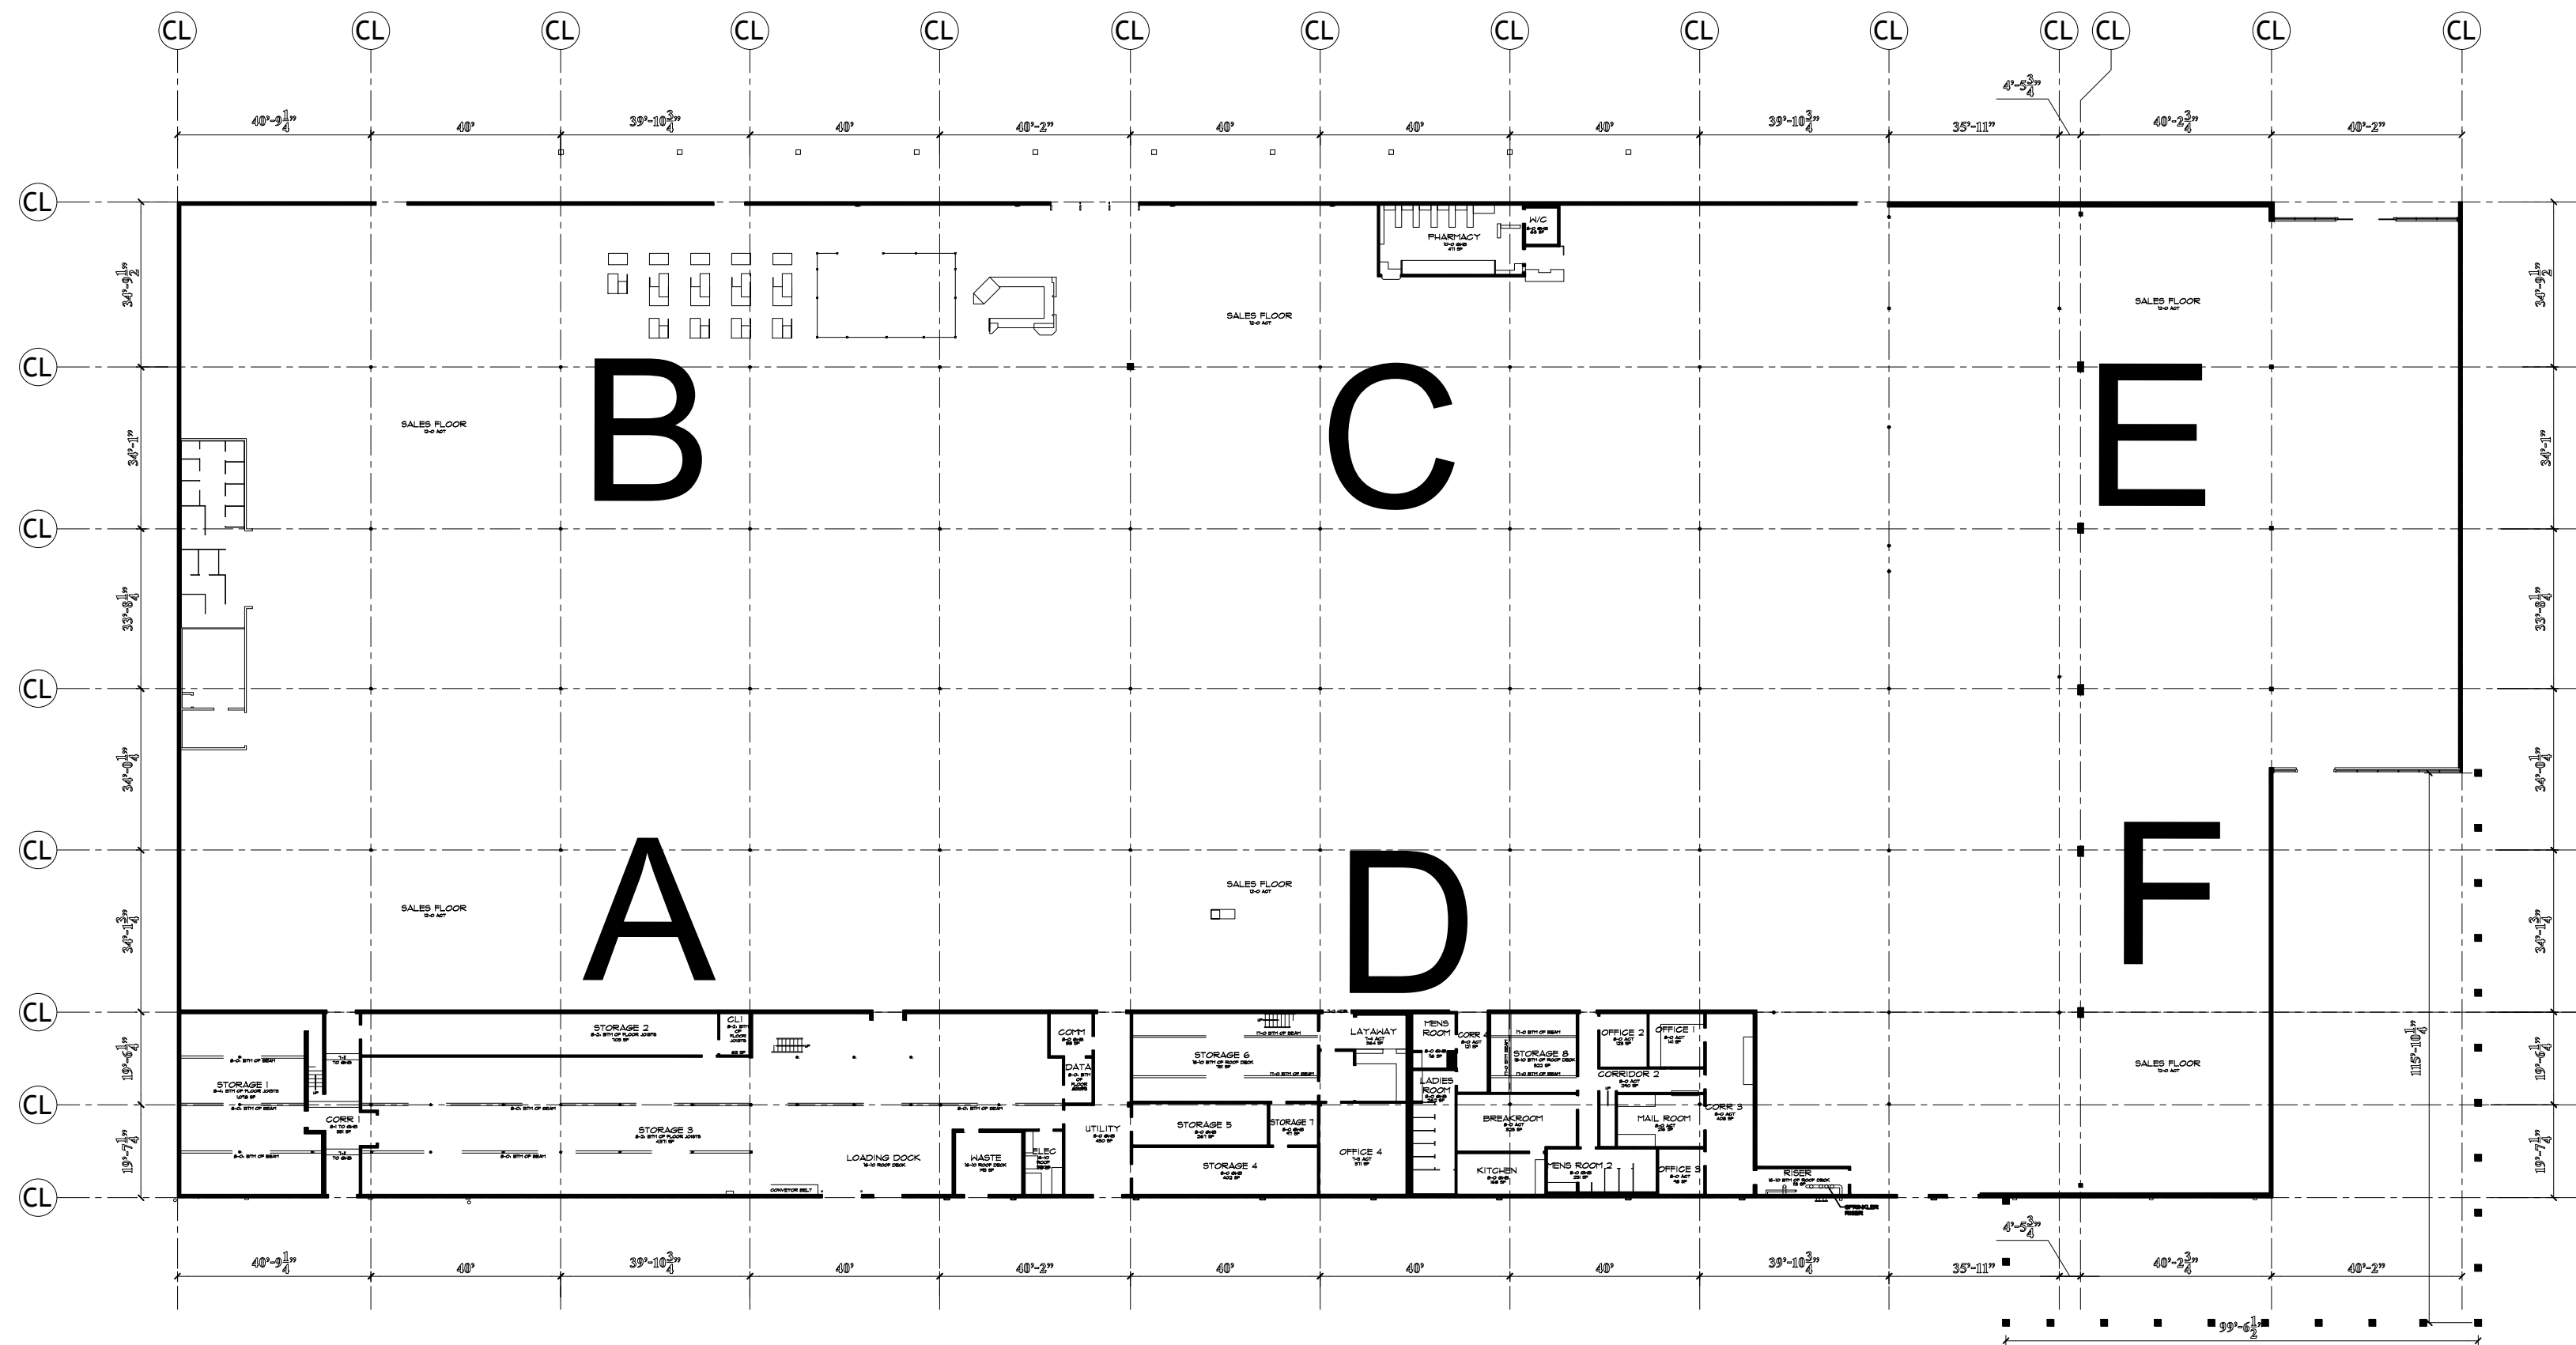

MAIN FLOOR PLAN
SCALE: 1/32" = 1'-0"

LEGEND	
⊙	THERMOSTAT
⊠	FLOOR DRAIN
⊞	ELEC PANEL
⊥	HOSE BIB
⊥	WATER SUPPLY
⊞	SUSPENDED GAS HEATER

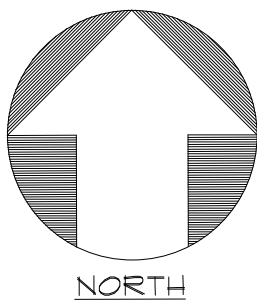

As BUILT

PROFESSIONALS

www.asbuiltprofessionals.com

A DIVISION OF:

AEC

CONSULTANTS INC


844.272.8458

844 AS BUILT

© 2020 AEC CONSULTANTS INC


ARCHITECTURAL AS BUILT
SUNRISE MOUNTAIN PLAZA
LAS VEGAS, NV 89110

01	100% SUBMISSION	
NO.	ISSUES REVISIONS	DATE
SHEET TITLE		
FLOORPLAN		
HL	PROJECT MANAGER	
HL	PROJECT DIRECTOR	
	PROJECT NUMBER	
1/32"=1'-0"	SCALE	
MM	DRAWN BY	
SHEET NUMBER		
AB-2		

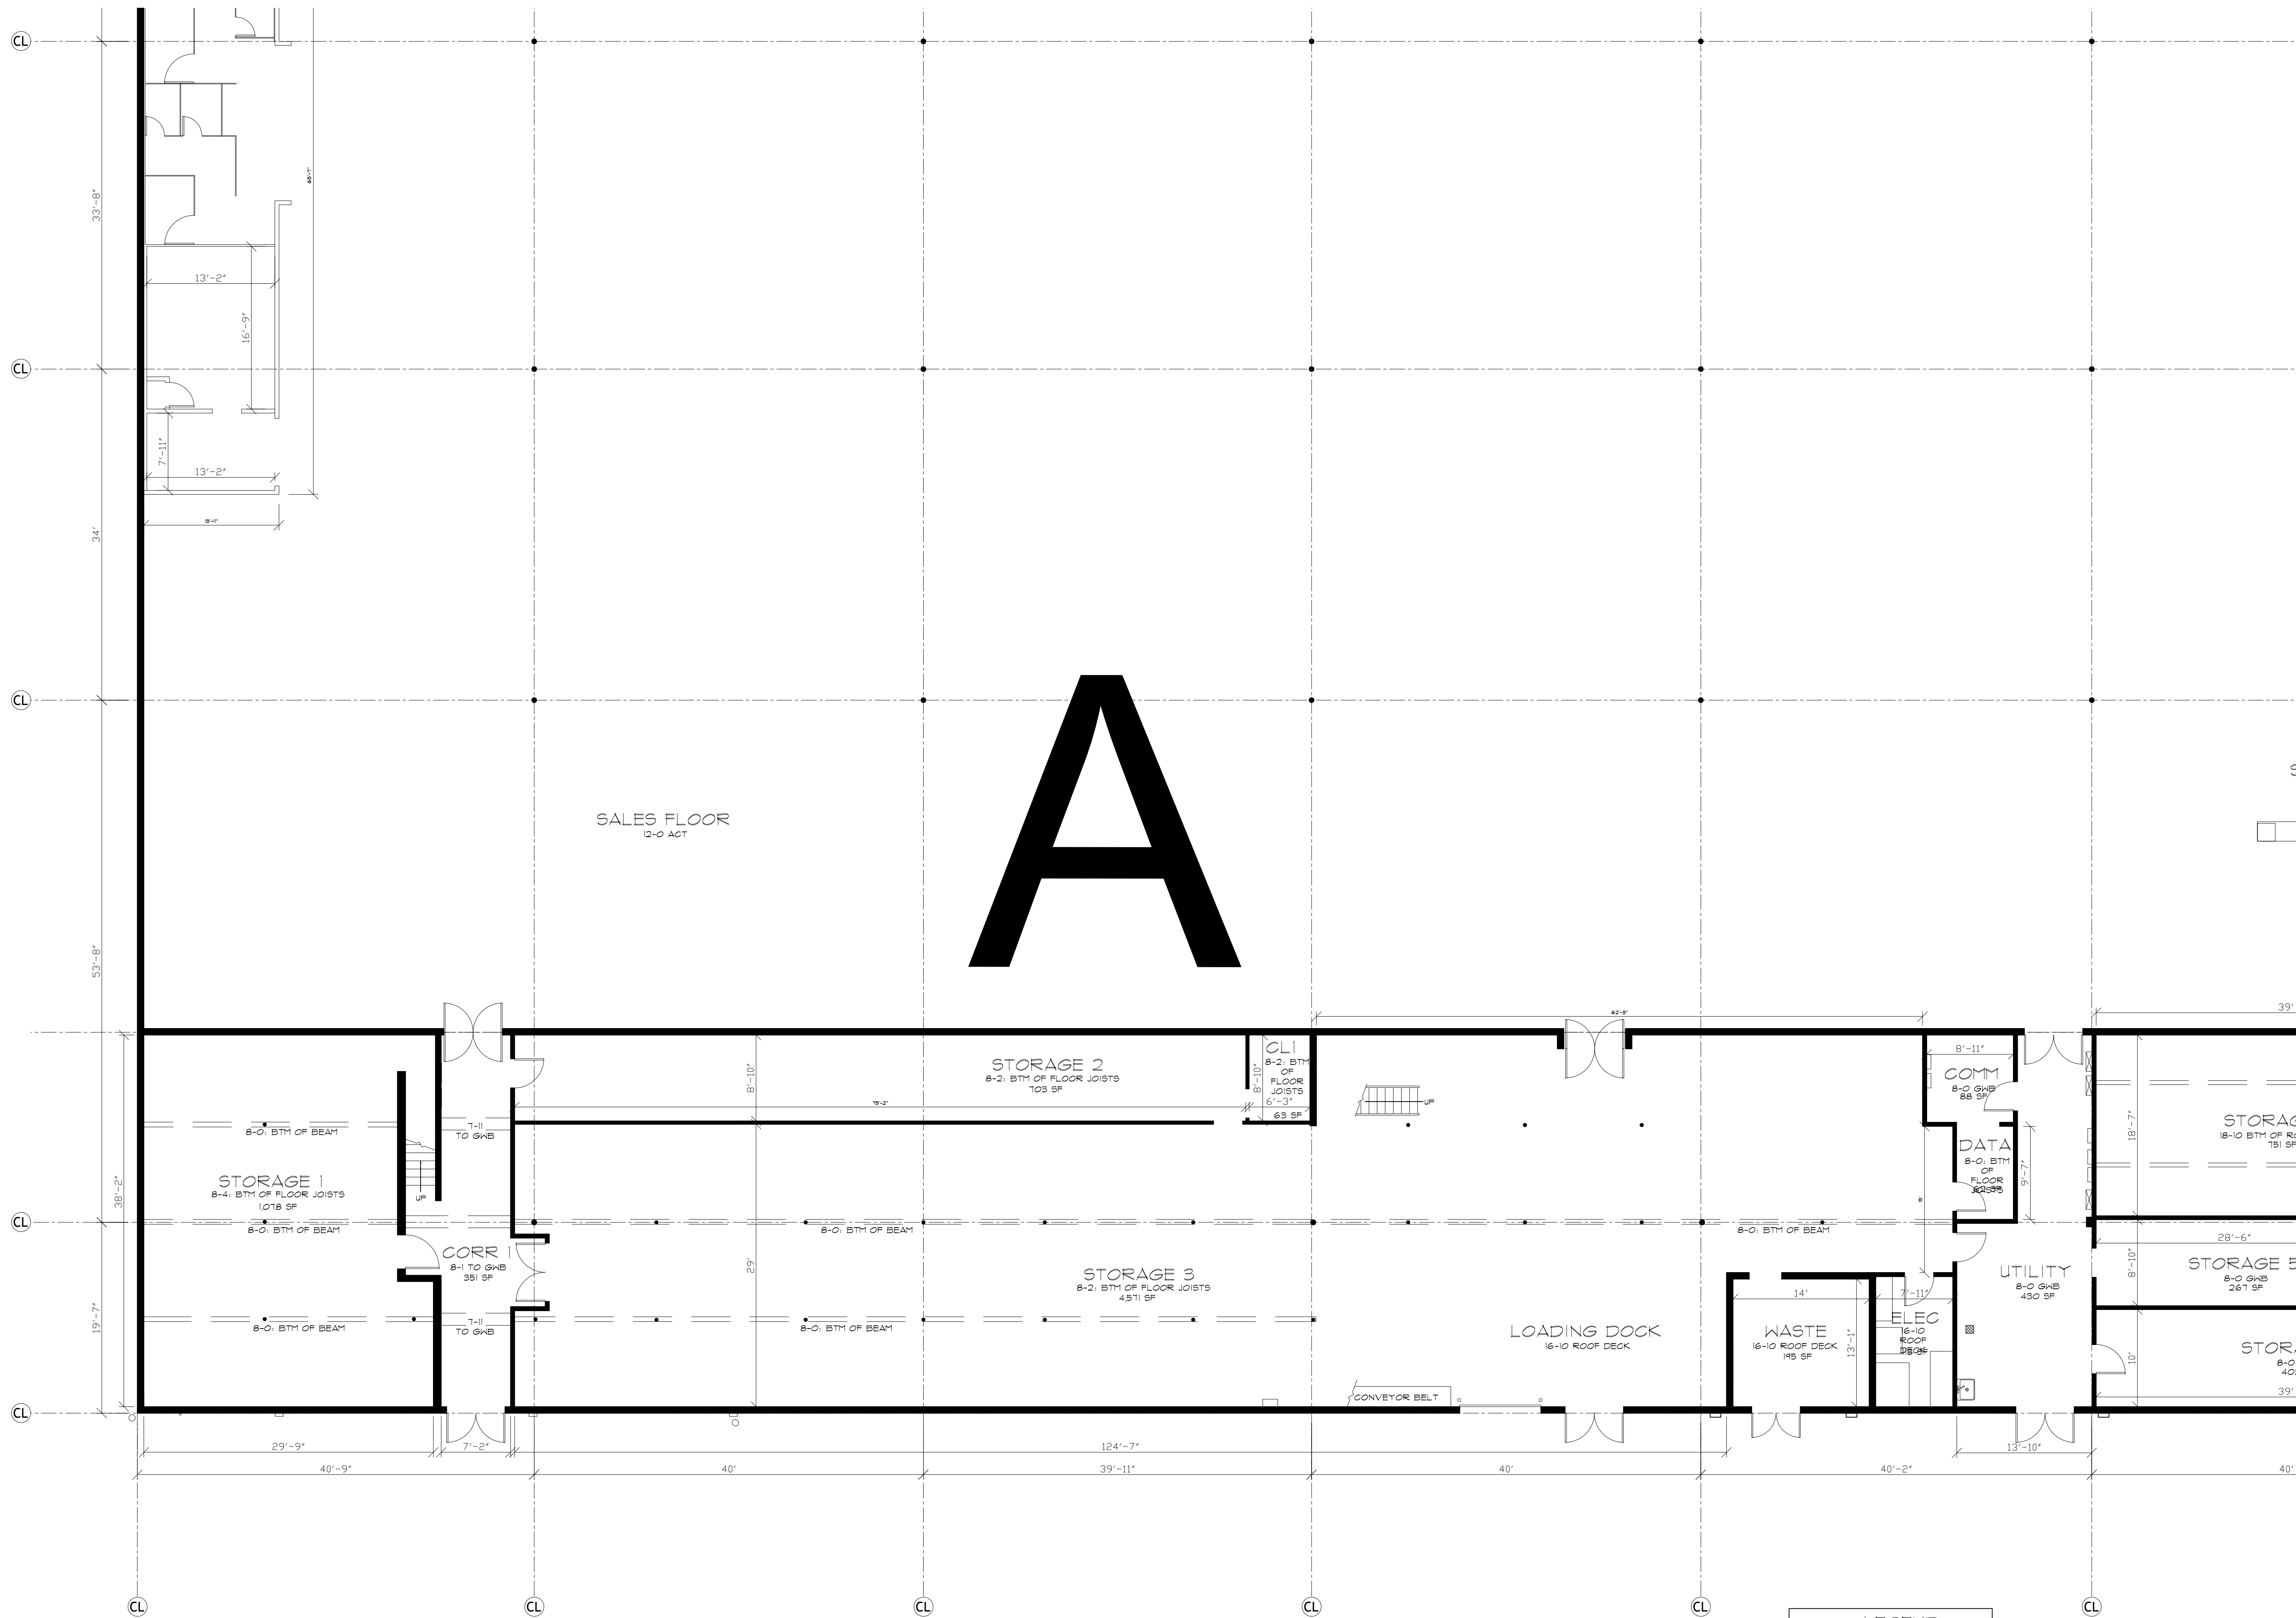

MAIN FLOOR PLAN - ENLARGED
SCALE: 1/8" = 1'-0"

LEGEND	
	THERMOSTAT
	FLOOR DRAIN
	ELEC PANEL
	HOSE BIB
	WATER SUPPLY
	SUSPENDED GAS HEATER

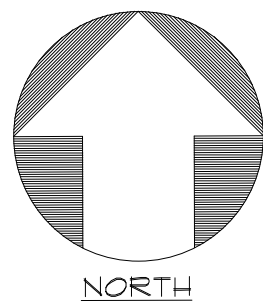

As BUILT

PROFESSIONALS

www.asbuiltprofessionals.com

A DIVISION OF:

AEC

CONSULTANTS INC

844.272.8458

844 AS BUILT

© 2020 AEC CONSULTANTS INC


ARCHITECTURAL AS BUILT
SUNRISE MOUNTAIN PLAZA
LAS VEGAS, NV 89110

01	100% SUBMISSION	
NO.	ISSUES REVISIONS	DATE
SHEET TITLE		

ENLARGED FLOORPLAN


HL	PROJECT MANAGER
HL	PROJECT DIRECTOR
	PROJECT NUMBER
1/8"=1'-0"	SCALE
MM	DRAWN BY
	SHEET NUMBER

AB-3

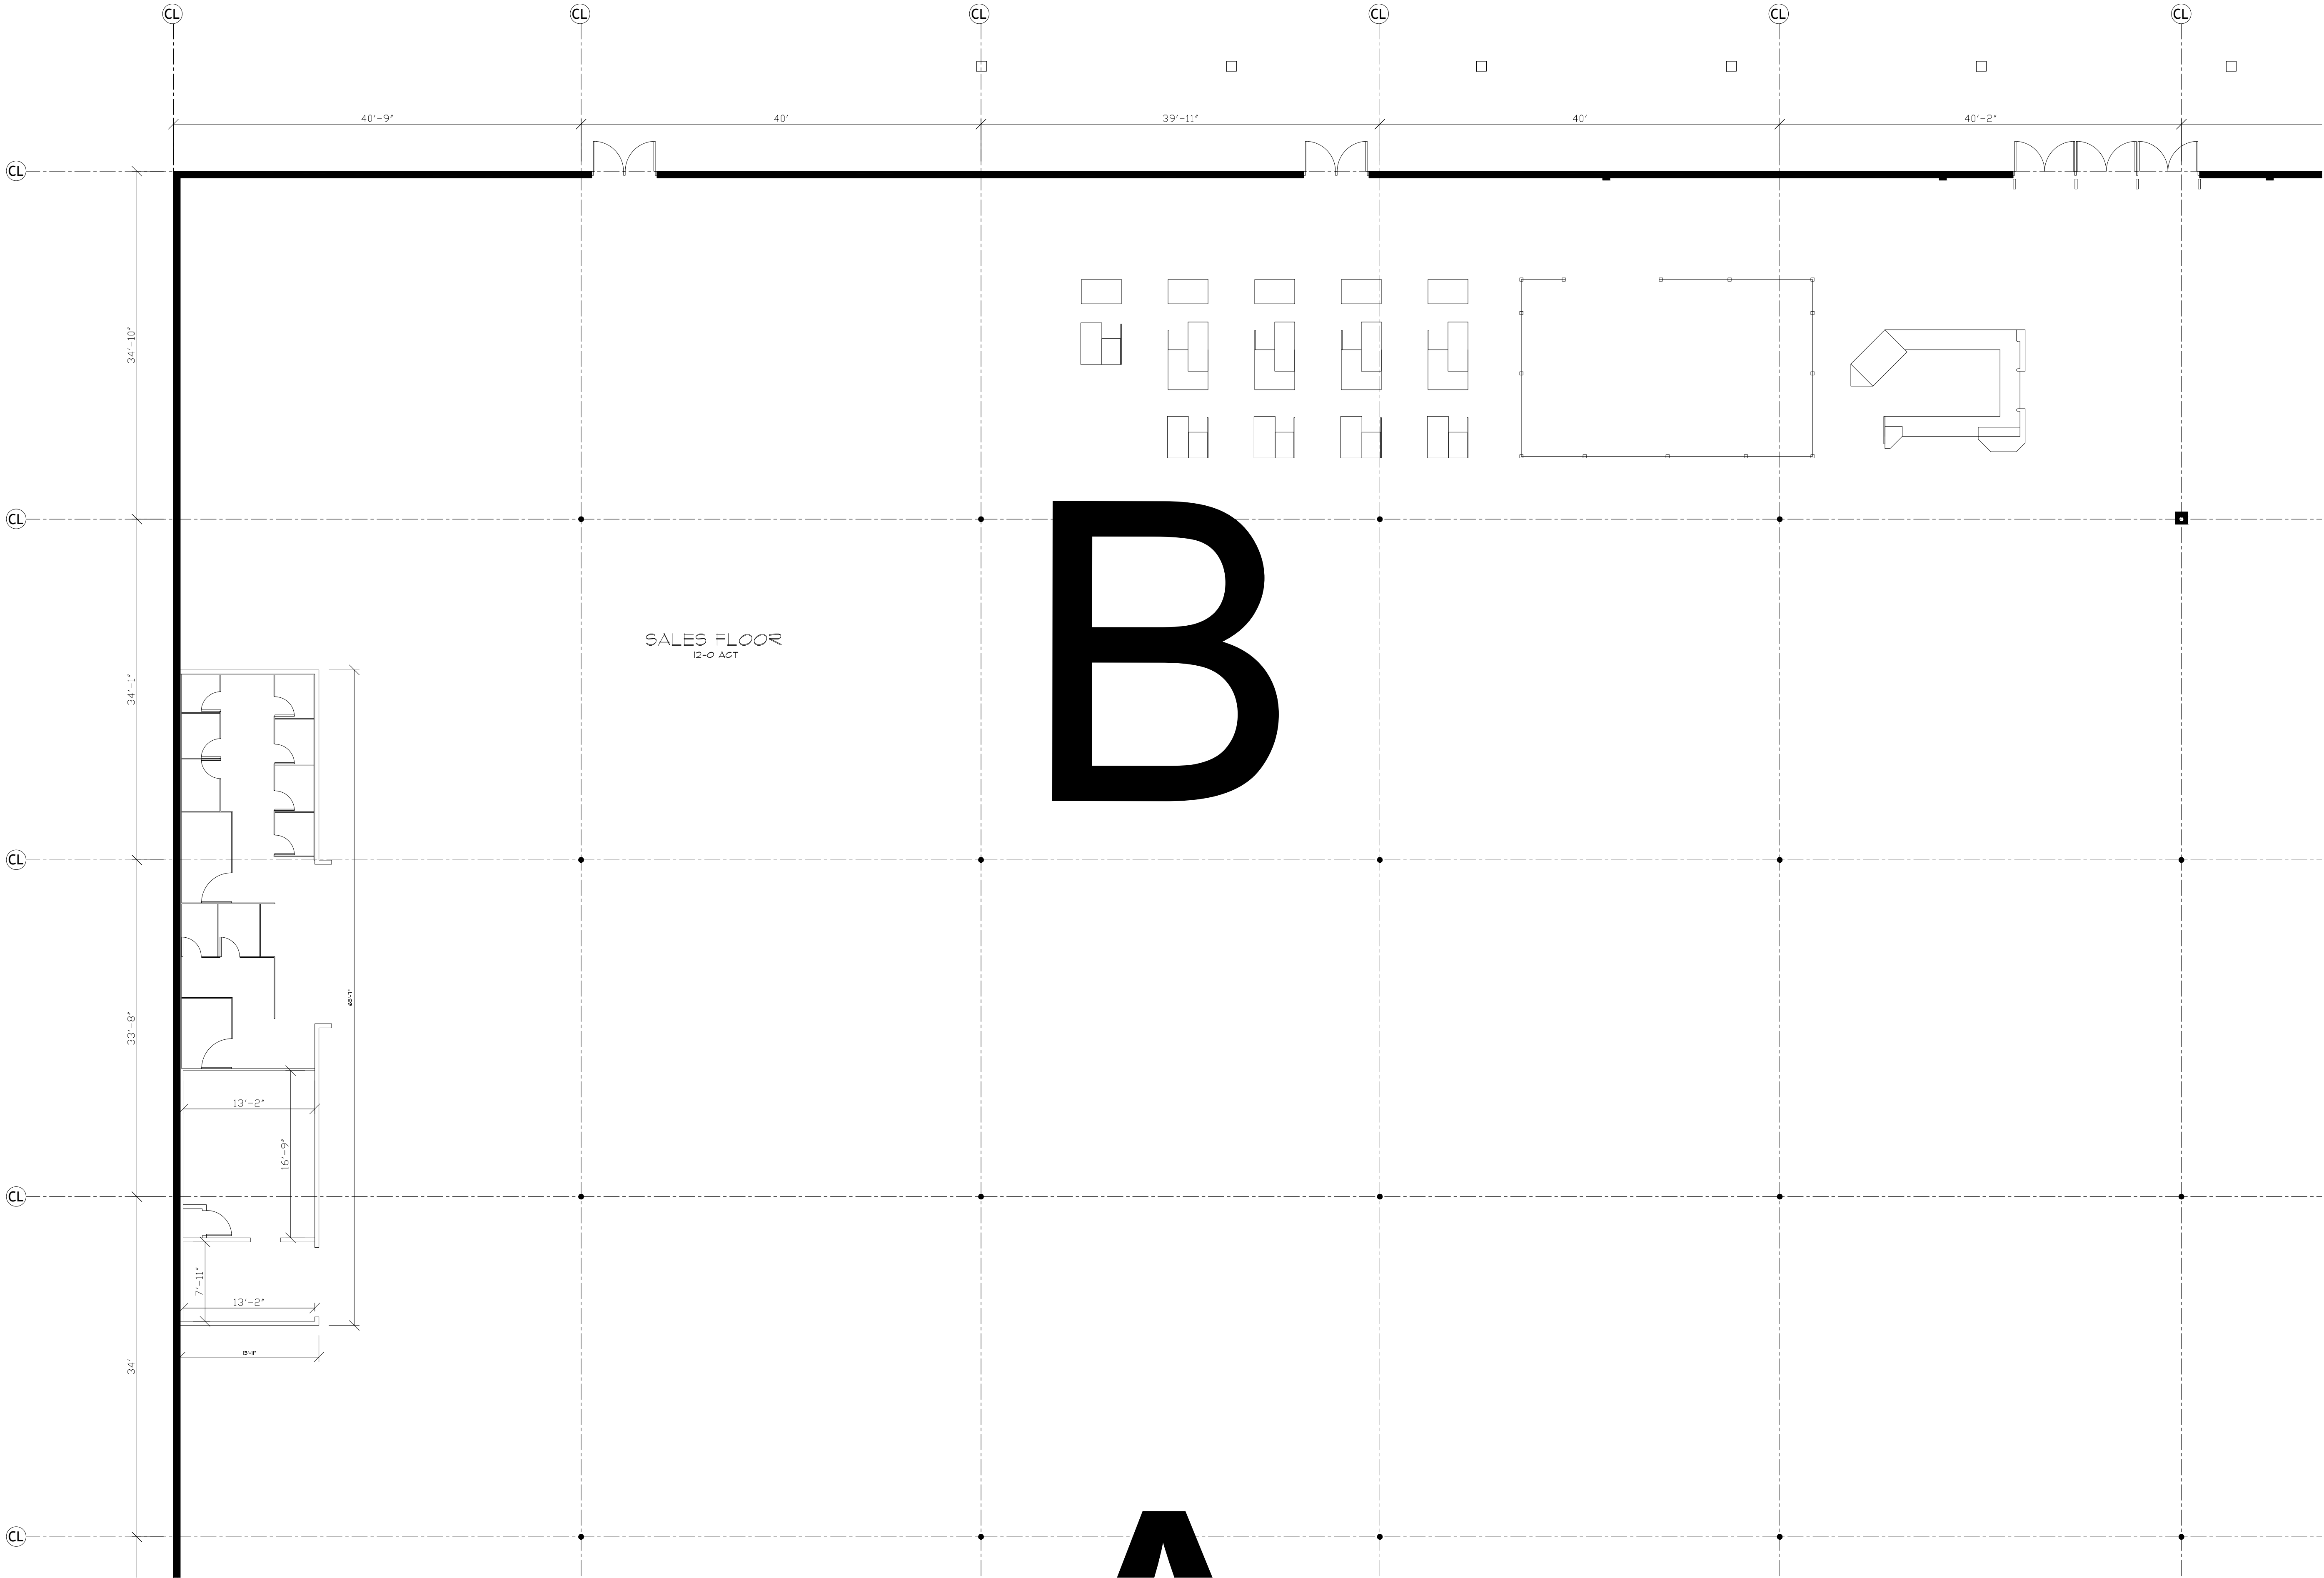

MAIN FLOOR PLAN - ENLARGED
SCALE: 1/8" = 1'-0"

LEGEND	
	THERMOSTAT
	FLOOR DRAIN
	ELEC PANEL
	HOSE BIB
	WATER SUPPLY
	SUSPENDED GAS HEATER

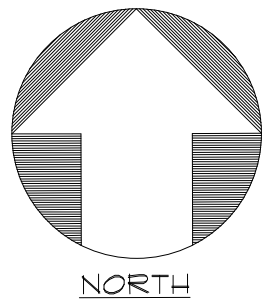



As BUILT
PROFESSIONALS
www.asbuiltprofessionals.com
A DIVISION OF:




AEC
CONSULTANTS INC
844.272.8458
844 ASBUILT

© 2020 AEC CONSULTANTS INC

ARCHITECTURAL AS BUILT
SUNRISE MOUNTAIN PLAZA
LAS VEGAS, NV 89110

01	100% SUBMISSION	
NO.	ISSUES REVISIONS	DATE
SHEET TITLE		
ENLARGED FLOORPLAN		
HL	PROJECT MANAGER	
HL	PROJECT DIRECTOR	
	PROJECT NUMBER	
	SCALE	
1/8"=1'-0"		
MM	DRAWN BY	
	SHEET NUMBER	

AB-4

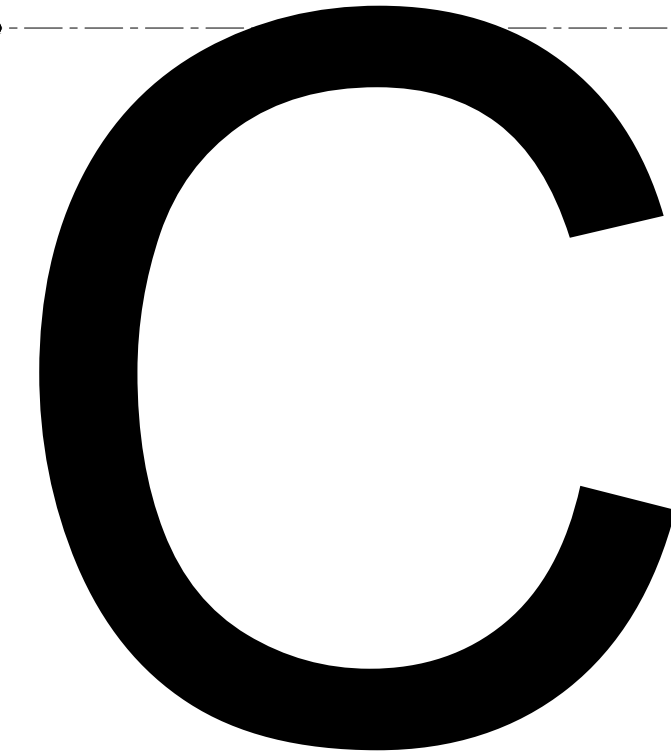

MAIN FLOOR PLAN - ENLARGED



ARCHITECTURAL AS BUILT

SUNRISE MOUNTAIN PLAZA

LAS VEGAS, NV 89110

ENLARGED FLOORPLAN

$$1/8'' = 1' - 0''$$

AB-5

ARCHITECTURAL AS BUILT
SUNRISE MOUNTAIN PLAZA
LAS VEGAS, NV 89110


01	100% SUBMISSION	DATE
NO.	ISSUES REVISIONS	DATE

SHEET TITLE

**ENLARGED
FLOORPLAN**

HL	PROJECT MANAGER
HL	PROJECT DIRECTOR
	PROJECT NUMBER
1/8"=1'-0"	SCALE
MM	DRAWN BY
	SHEET NUMBER


AB-6

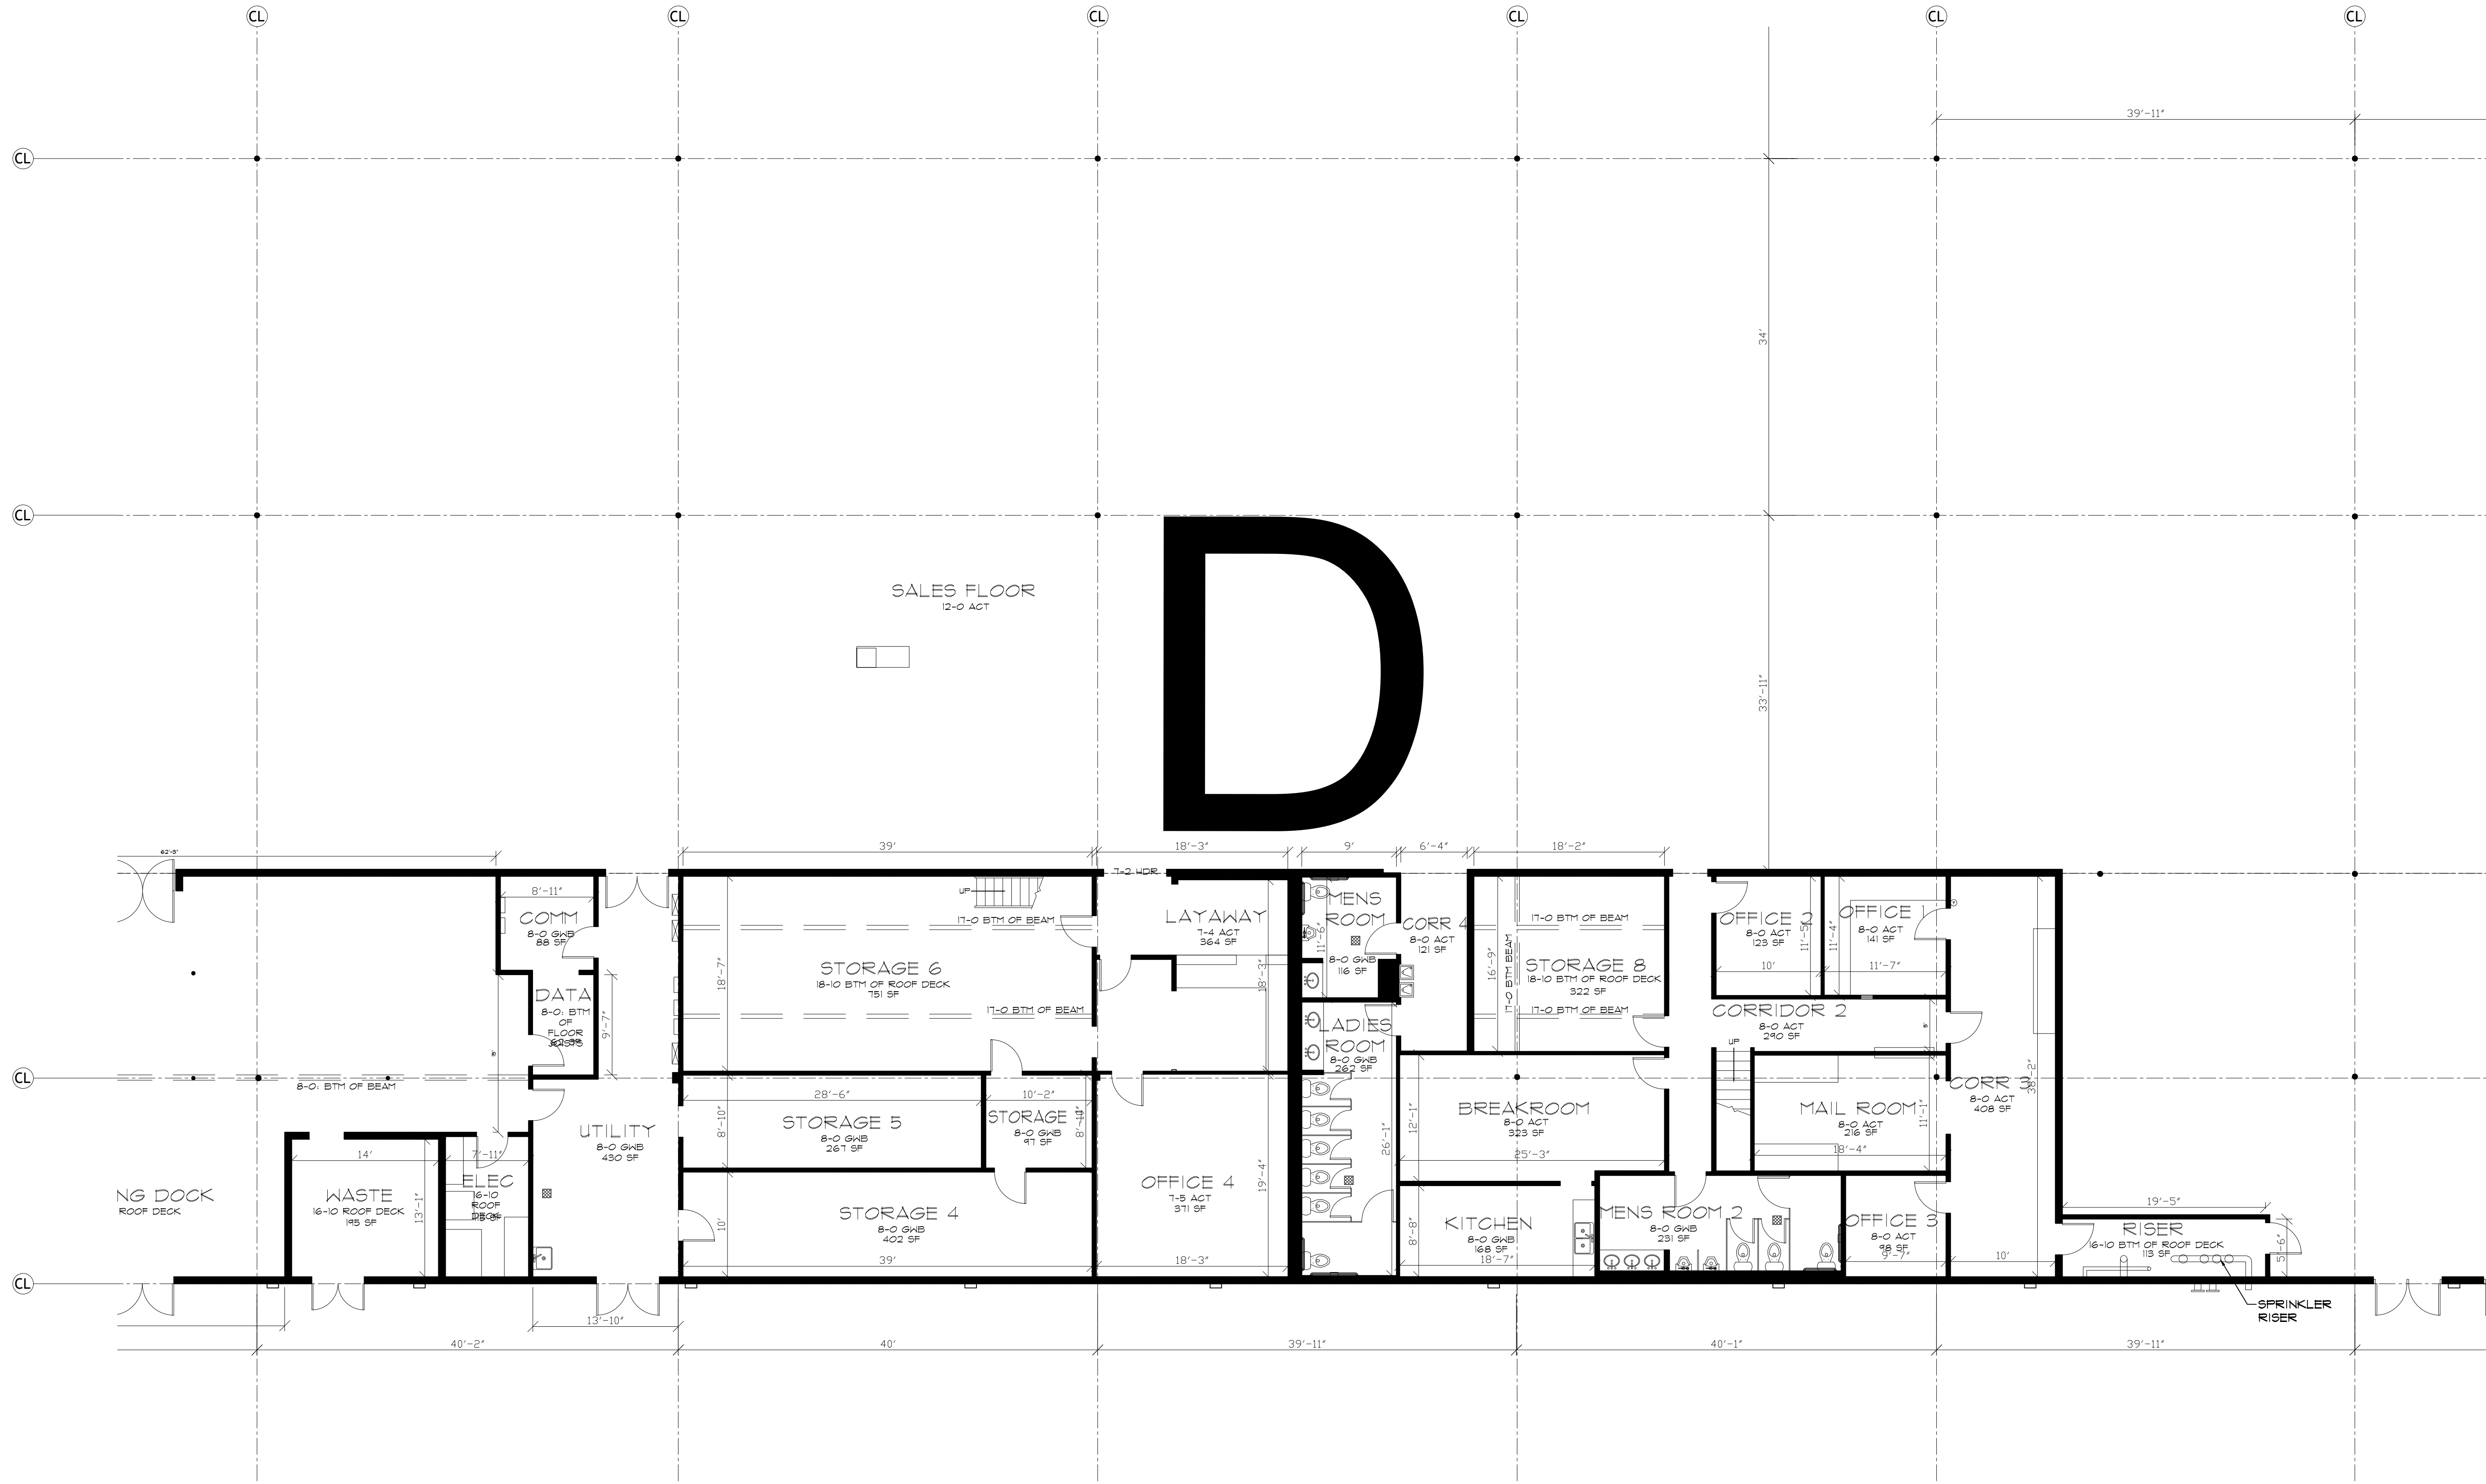


MAIN FLOOR PLAN - ENLARGED
SCALE: 1/8" = 1'-0"

LEGEND


- THERMOSTAT
- ⊞ FLOOR DRAIN
- ⊞ ELEC PANEL
- ⊞ HOSE BIB
- ⊞ WATER SUPPLY
- ⊞ SUSPENDED GAS HEATER

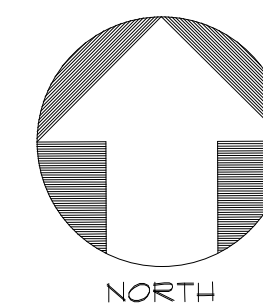

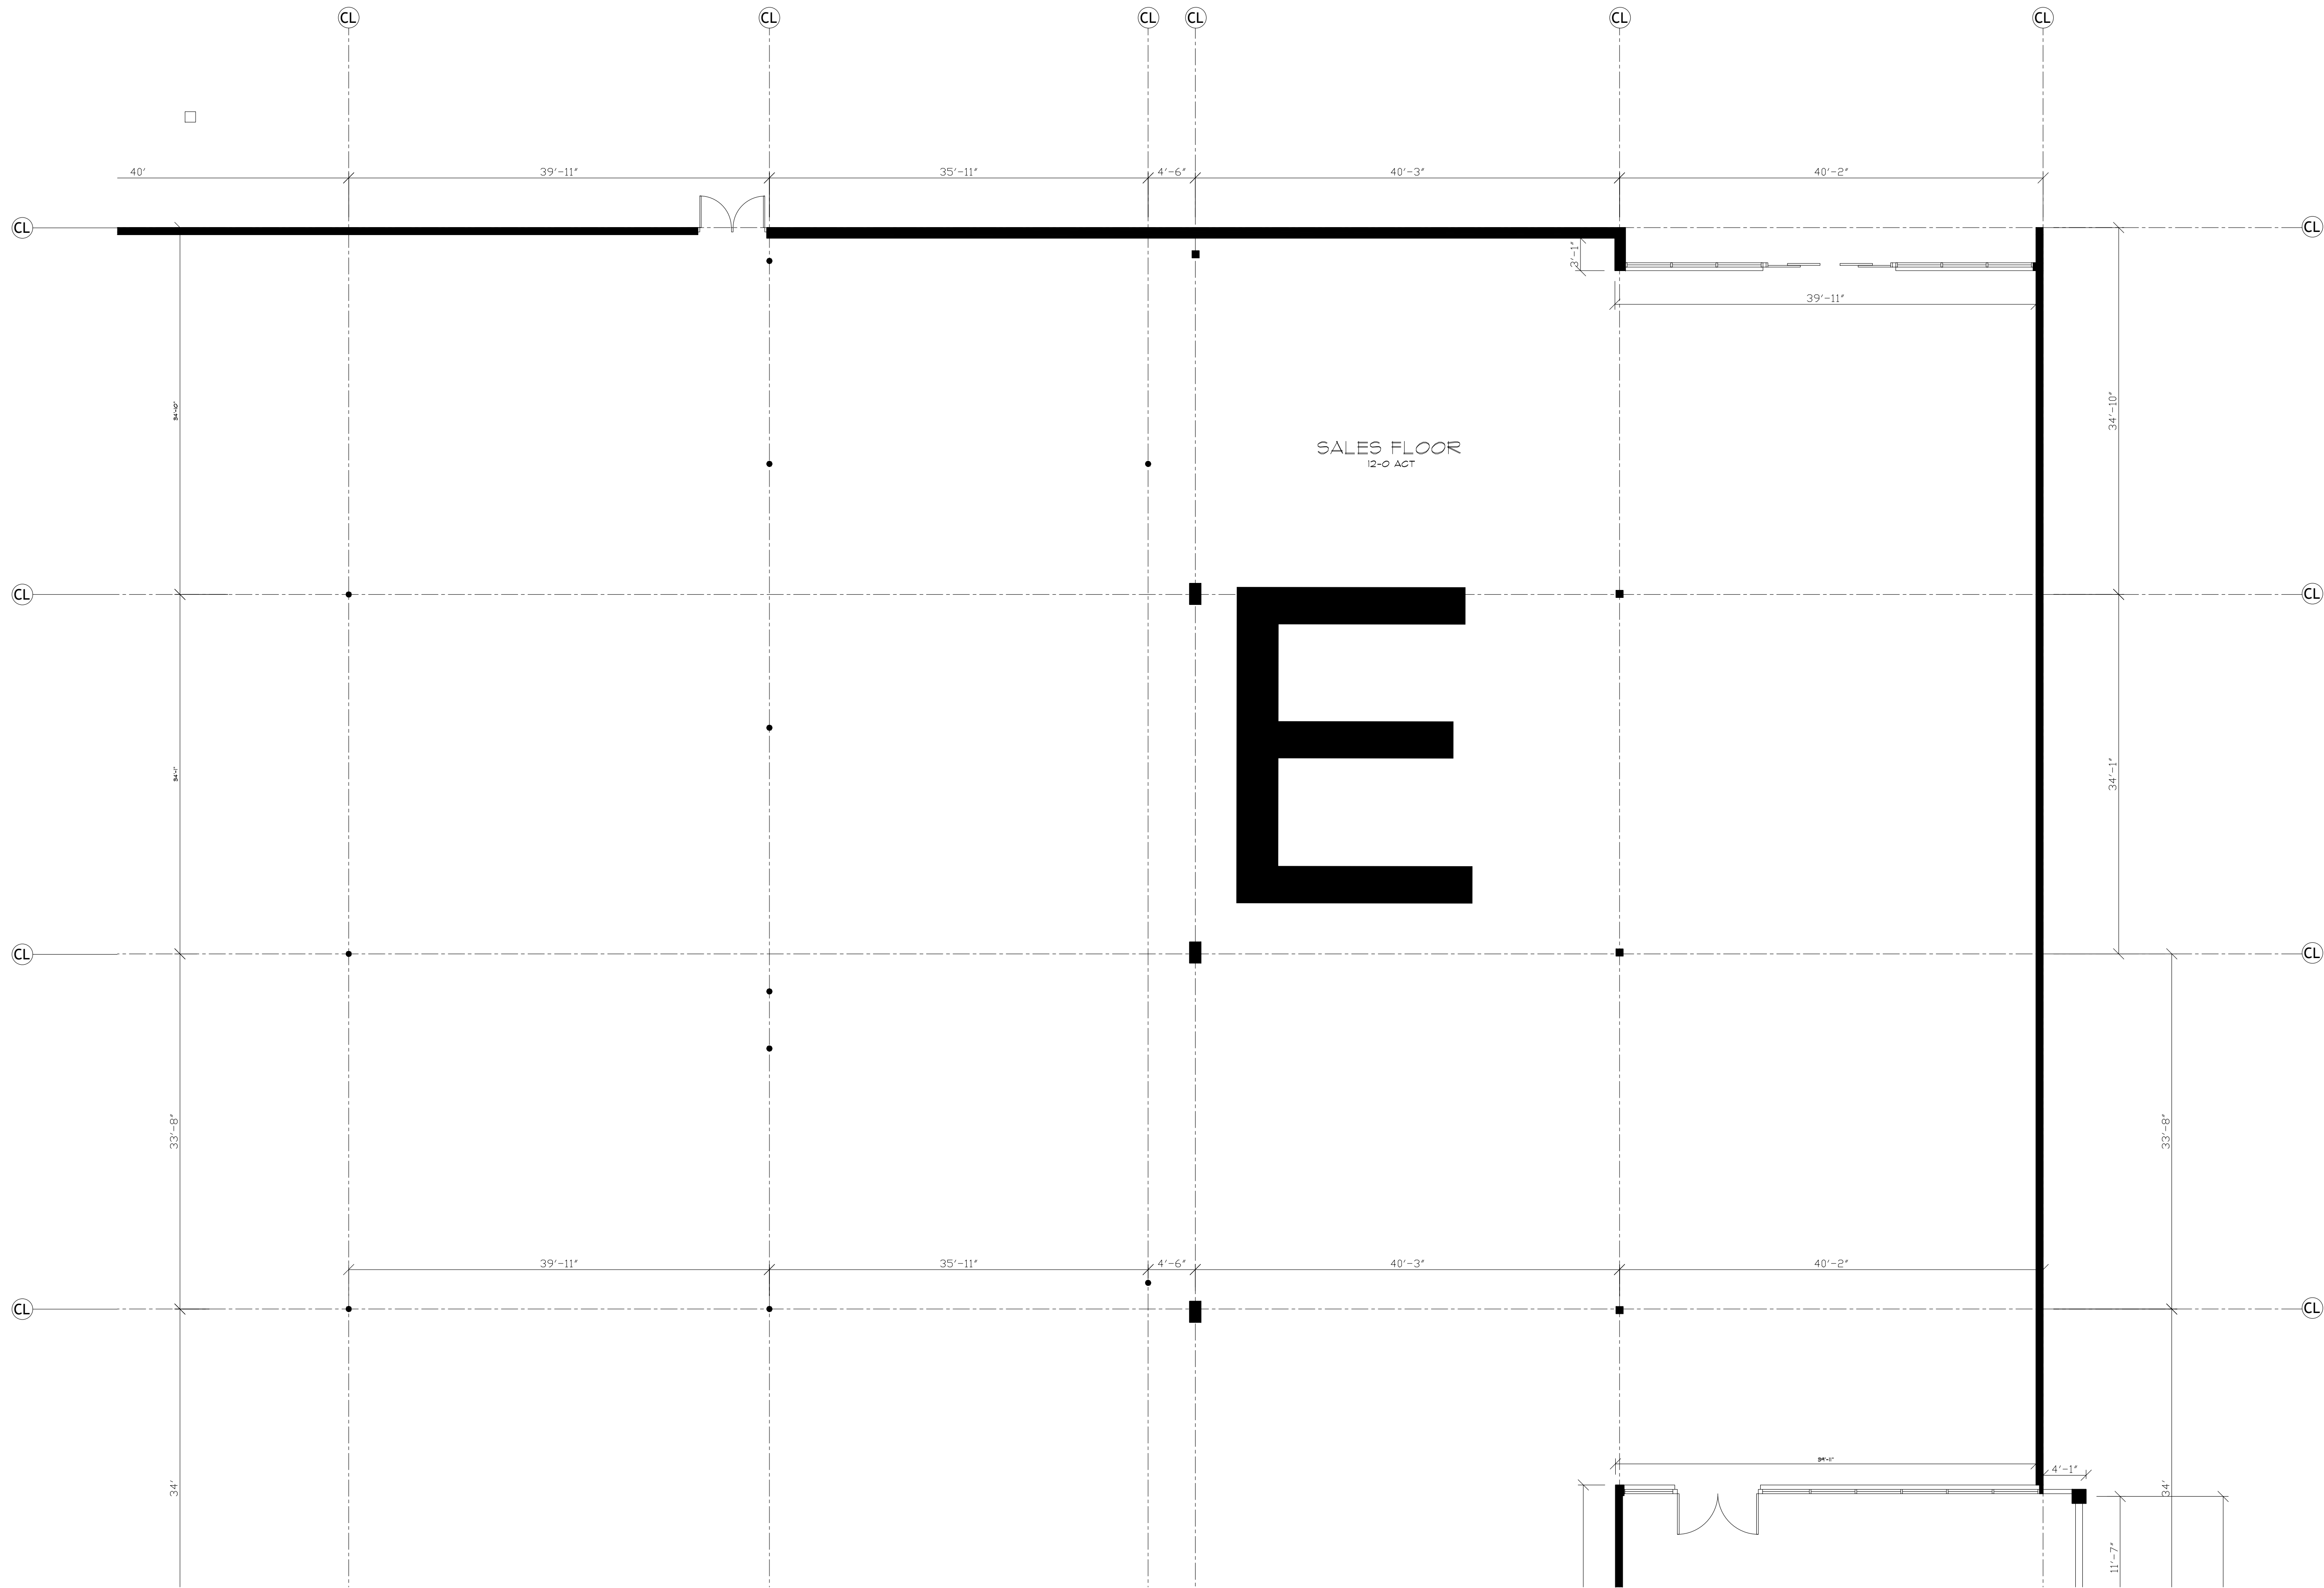

MAIN FLOOR PLAN - ENLARGED
SCALE: 1/8" = 1'-0"

LEGEND	
⊖	THERMOSTAT
⊗	FLOOR DRAIN
⊞	ELEC PANEL
T	HOSE BIB
↑	WATER SUPPLY
⊞	SUSPENDED GAS HEATER

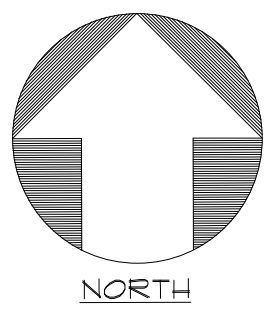

As BUILT

PROFESSIONALS

www.asbuiltprofessionals.com

A DIVISION OF:

AEC

CONSULTANTS INC


844.272.8458

844 AS BUILT

© 2020 AEC CONSULTANTS INC

ARCHITECTURAL AS BUILT
SUNRISE MOUNTAIN PLAZA
LAS VEGAS, NV 89110

01	100% SUBMISSION	
NO.	ISSUES REVISIONS	DATE
SHEET TITLE		
ENLARGED FLOORPLAN		
HL	PROJECT MANAGER	
HL	PROJECT DIRECTOR	
	PROJECT NUMBER	
1/8"=1'-0"	SCALE	
MM	DRAWN BY	
	SHEET NUMBER	
AB-7		

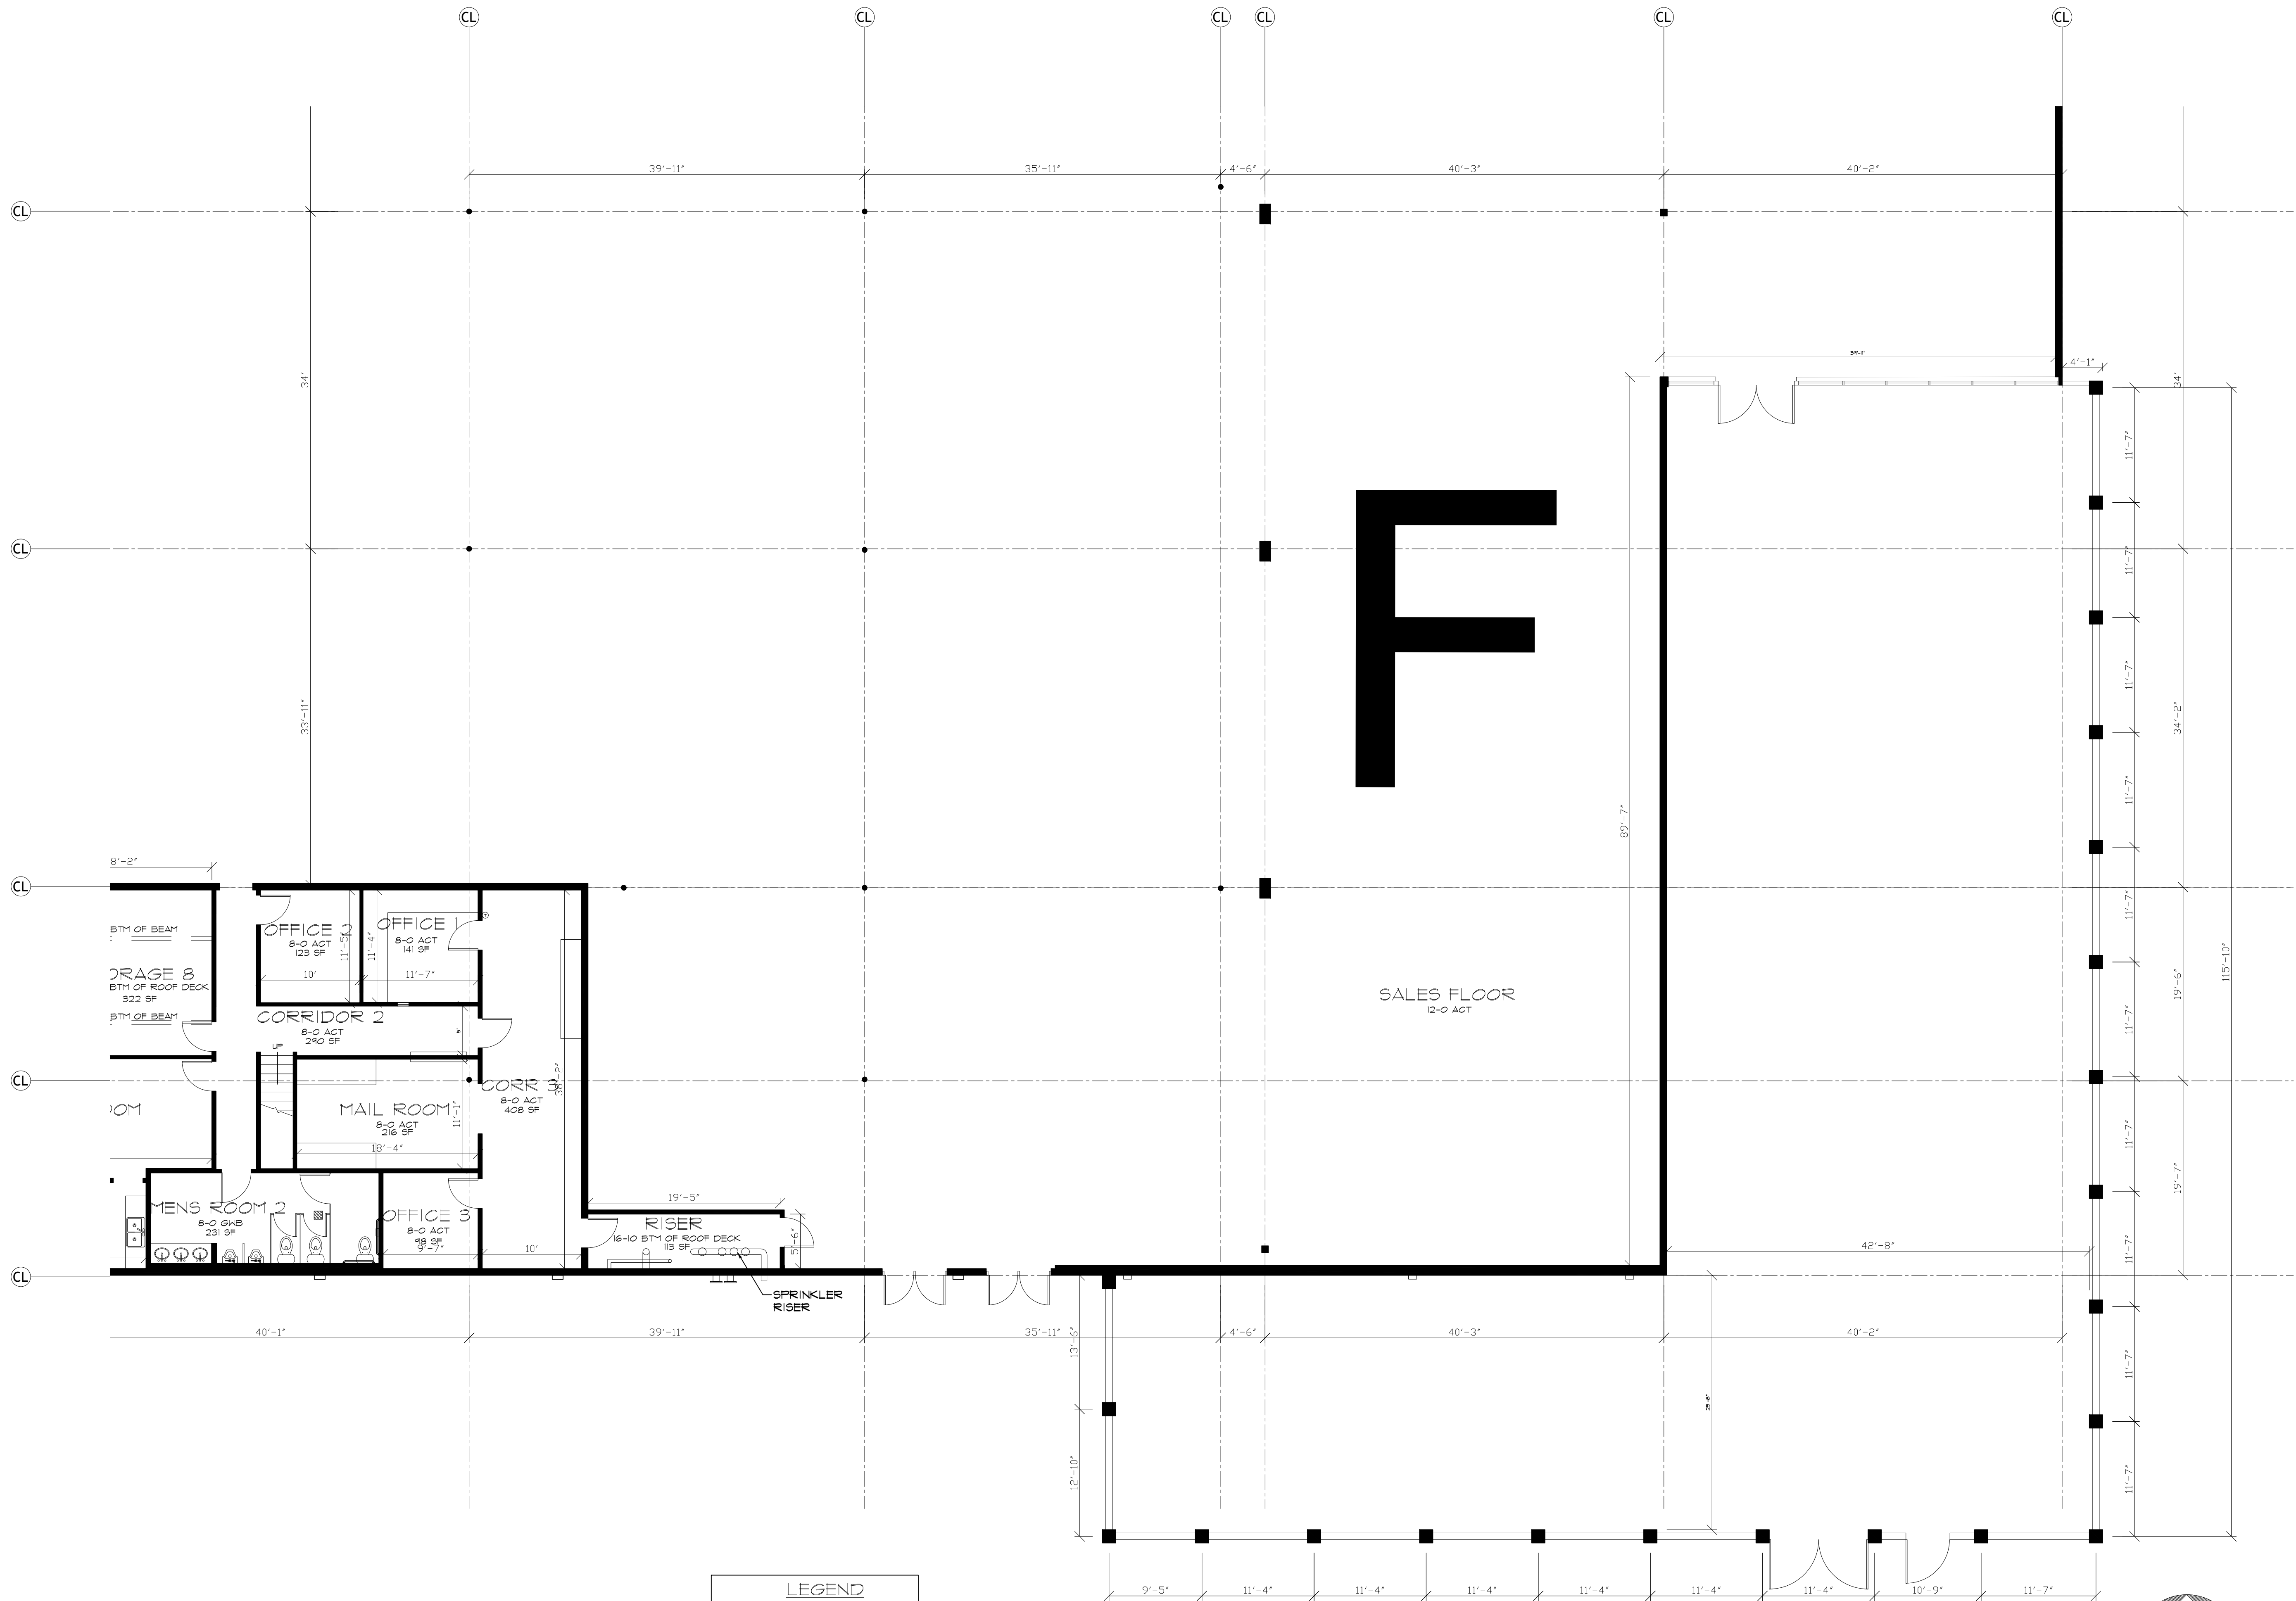

MAIN FLOOR PLAN - ENLARGED
SCALE: 1/8" = 1'-0"



AS BUILT
PROFESSIONALS
www.asbuiltprofessionals.com
A DIVISION OF:

AEC
CONSULTANTS INC
844.272.8458
844 AS BUILT

© 2020 AEC CONSULTANTS INC

ARCHITECTURAL AS BUILT
SUNRISE MOUNTAIN PLAZA
LAS VEGAS, NV 89110

01	100% SUBMISSION	DATE
NO.	ISSUES REVISIONS	DATE
SHEET TITLE		
ENLARGED FLOORPLAN		
HL	PROJECT MANAGER	
HL	PROJECT DIRECTOR	
	PROJECT NUMBER	
1/8"=1'-0"	SCALE	
MM	DRAWN BY	
	SHEET NUMBER	
AB-8		

 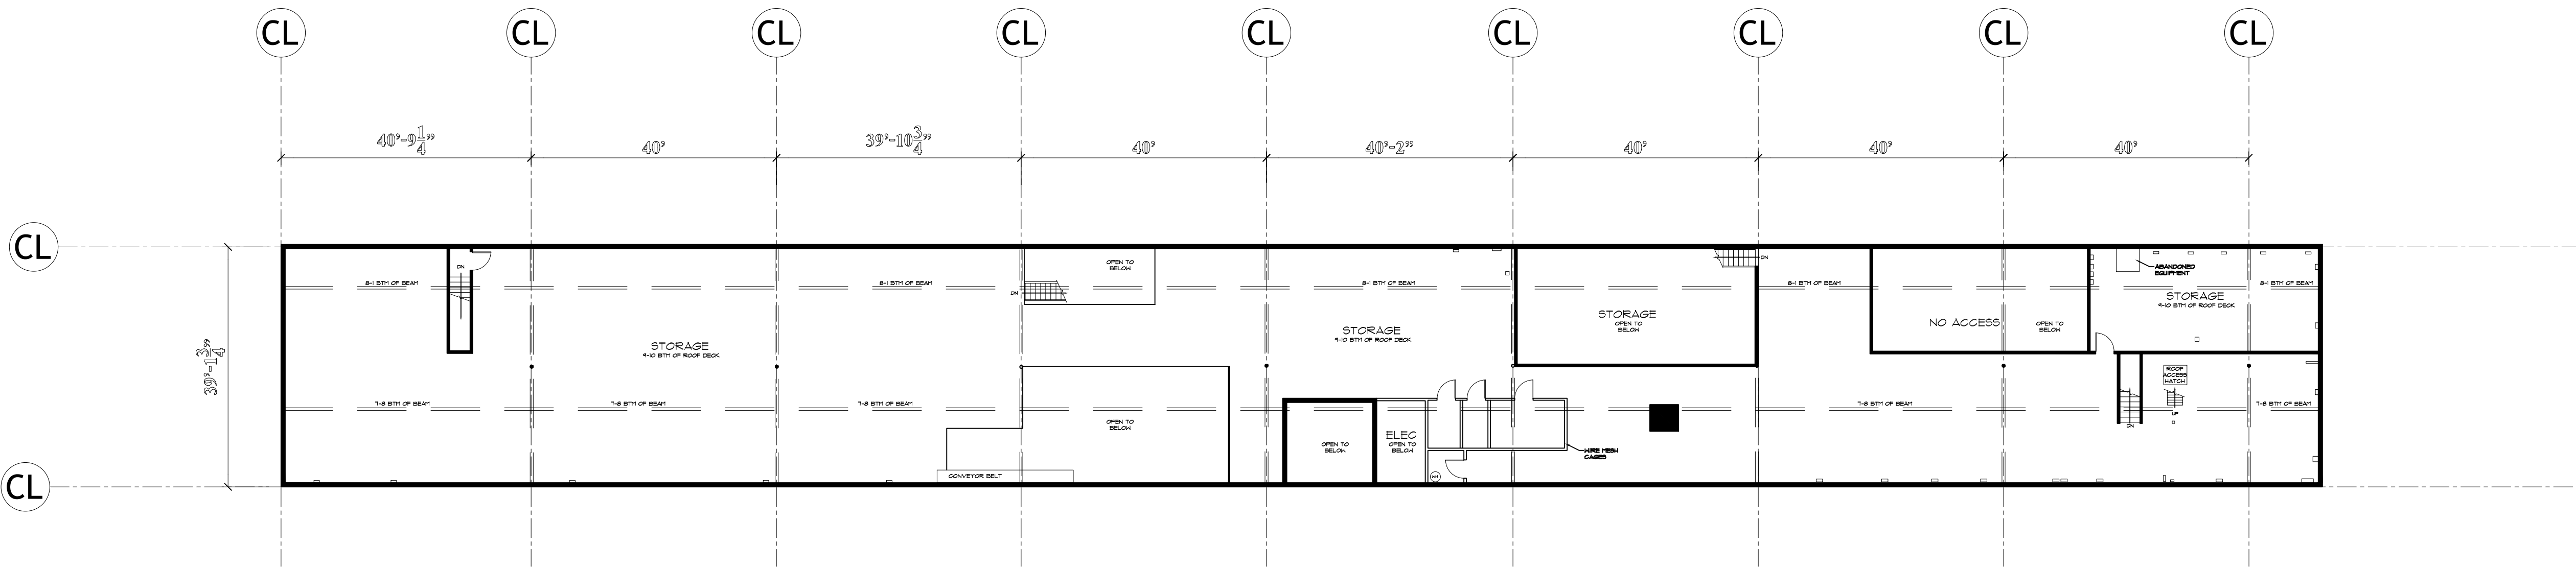

MEZZANINE PLAN
SCALE: 1/16" = 1'-0"

LEGEND	
	THERMOSTAT
	FLOOR DRAIN
	ELEC PANEL
	HOSE BIB
	WATER SUPPLY
	SUSPENDED GAS HEATER

As BUILT

PROFESSIONALS

www.asbuiltprofessionals.com

A DIVISION OF:

AEC

CONSULTANTS INC


844.272.8458

844 AS BUILT

© 2020 AEC CONSULTANTS INC


ARCHITECTURAL AS BUILT
SUNRISE MOUNTAIN PLAZA
LAS VEGAS, NV 89110

01	100% SUBMISSION	
NO.	ISSUES REVISIONS	DATE
SHEET TITLE		
MEZZANINE PLAN		
HL	PROJECT MANAGER	
HL	PROJECT DIRECTOR	
	PROJECT NUMBER	
1/16"=1'-0"	SCALE	
MM	DRAWN BY	
SHEET NUMBER		
AB-9		

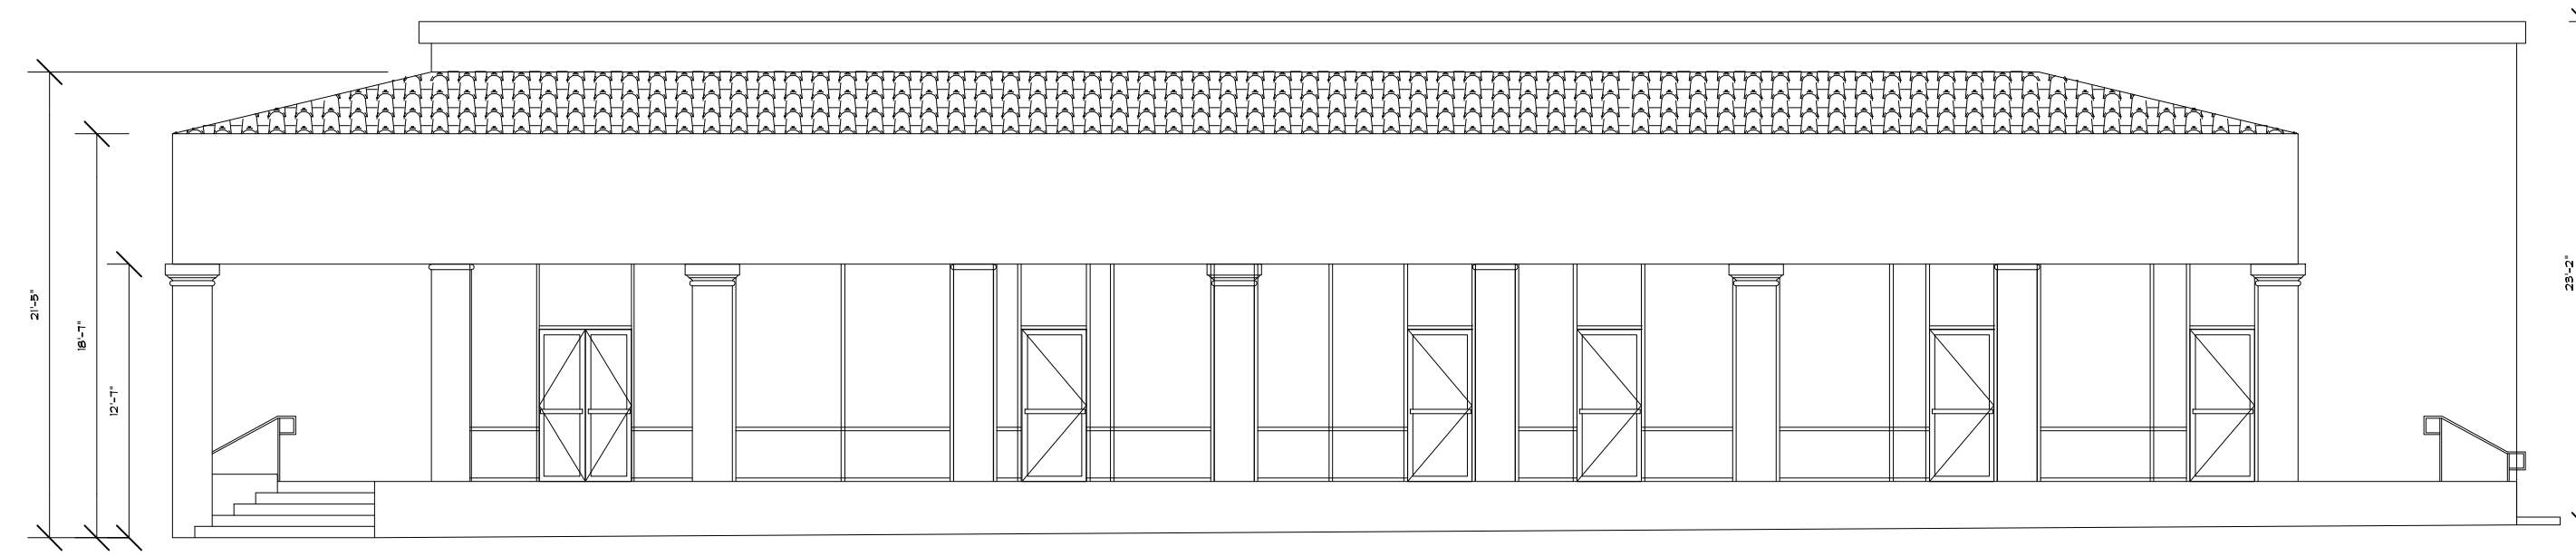


NORTH ELEVATION E1

SCALE: 1/8" = 1'-0"

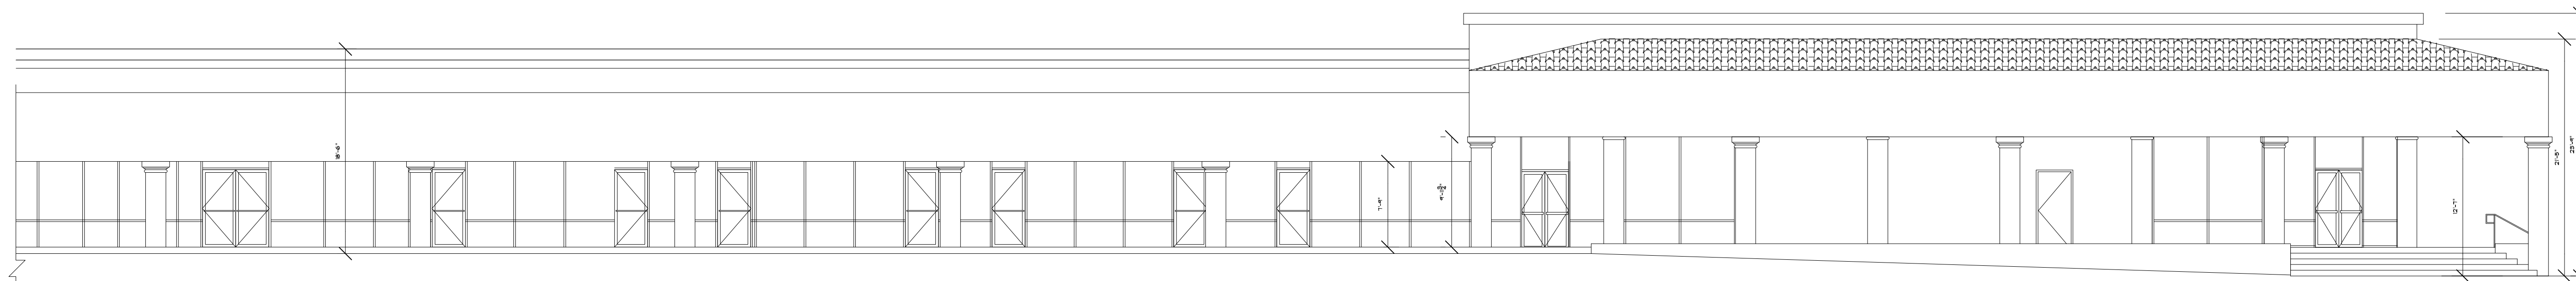

EAST ELEVATION E2

SCALE: 1/8" = 1'-0"

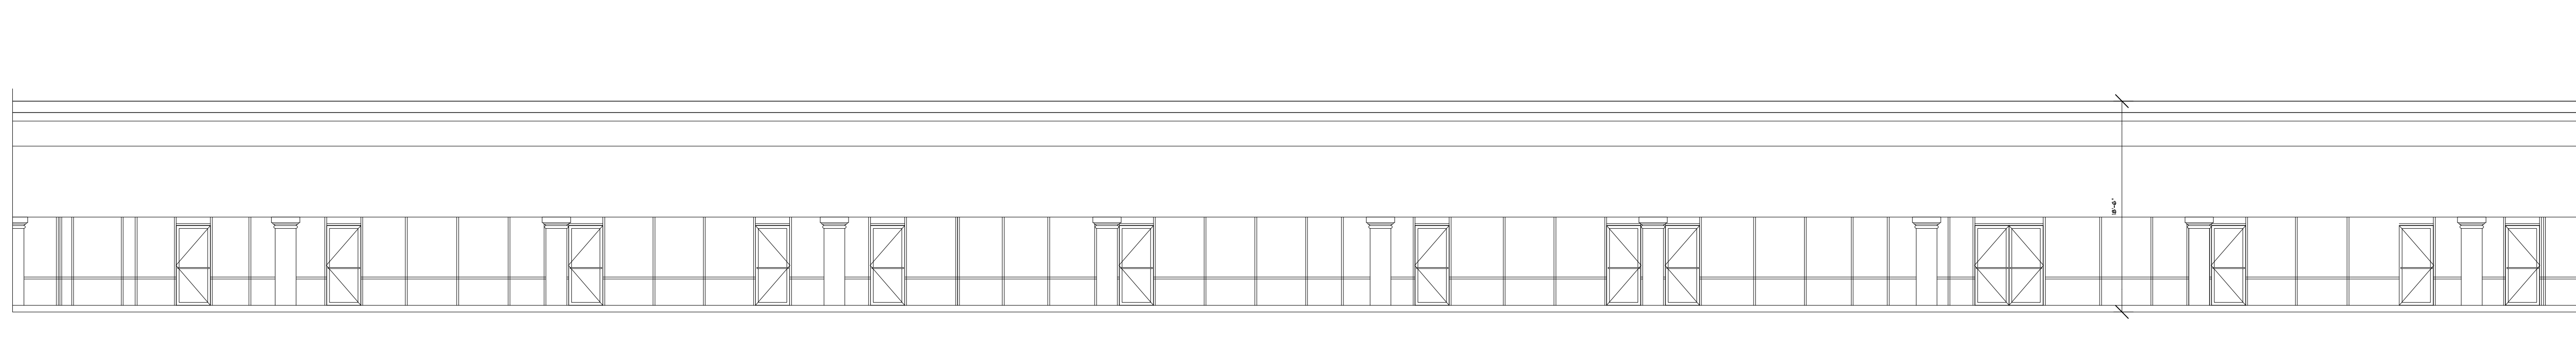

EAST ELEVATION E2

SCALE: 1/8" = 1'-0"




ARCHITECTURAL AS BUILT


SUNRISE MOUNTAIN PLAZA

LAS VEGAS, NV 89110

01	100% SUBMISSION	
NO.	ISSUES REVISIONS	DATE
		SHEET TITLE
EXTERIOR ELEVATIONS		
HL	PROJECT MANAGER	
HL	PROJECT DIRECTOR	
	PROJECT NUMBER	
1/8"=1'-0"	SCALE	
MM	DRAWN BY	
	SHEET NUMBER	
AB-10		

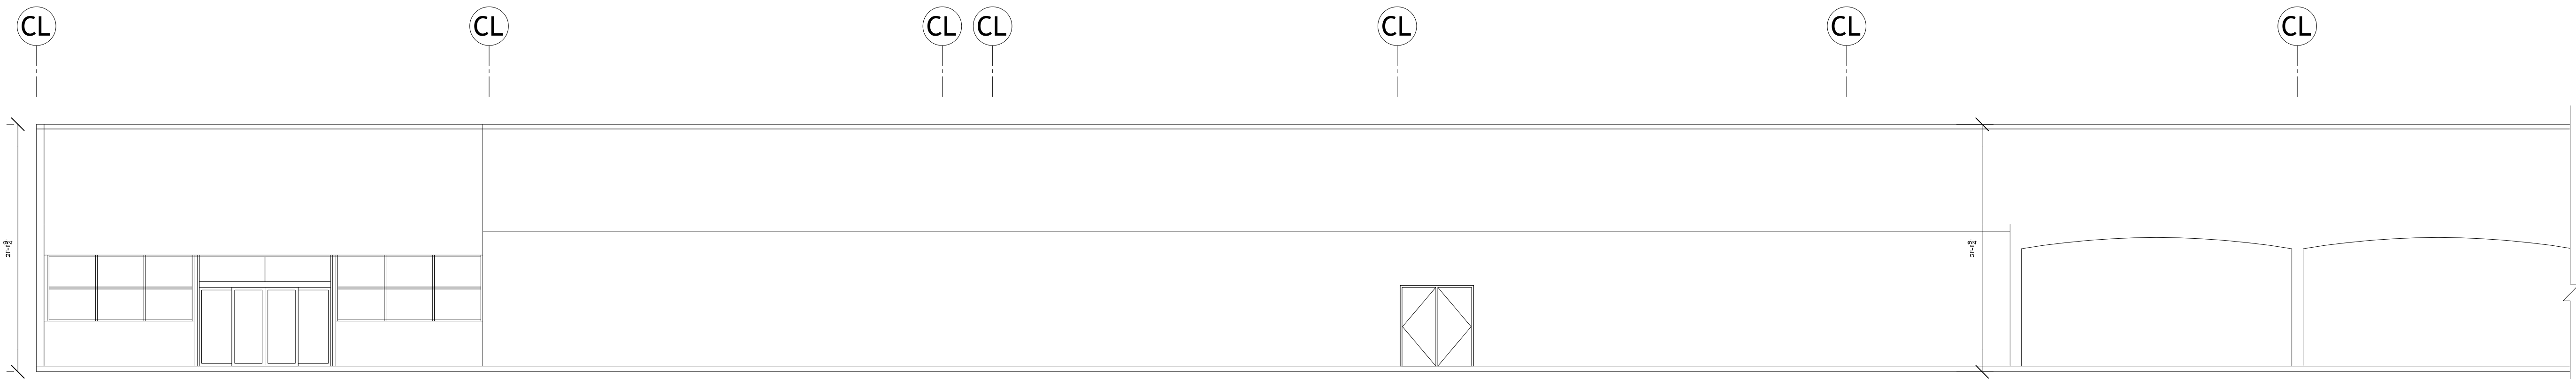

NORTH ELEVATION E3
SCALE: 1/8" = 1'-0"

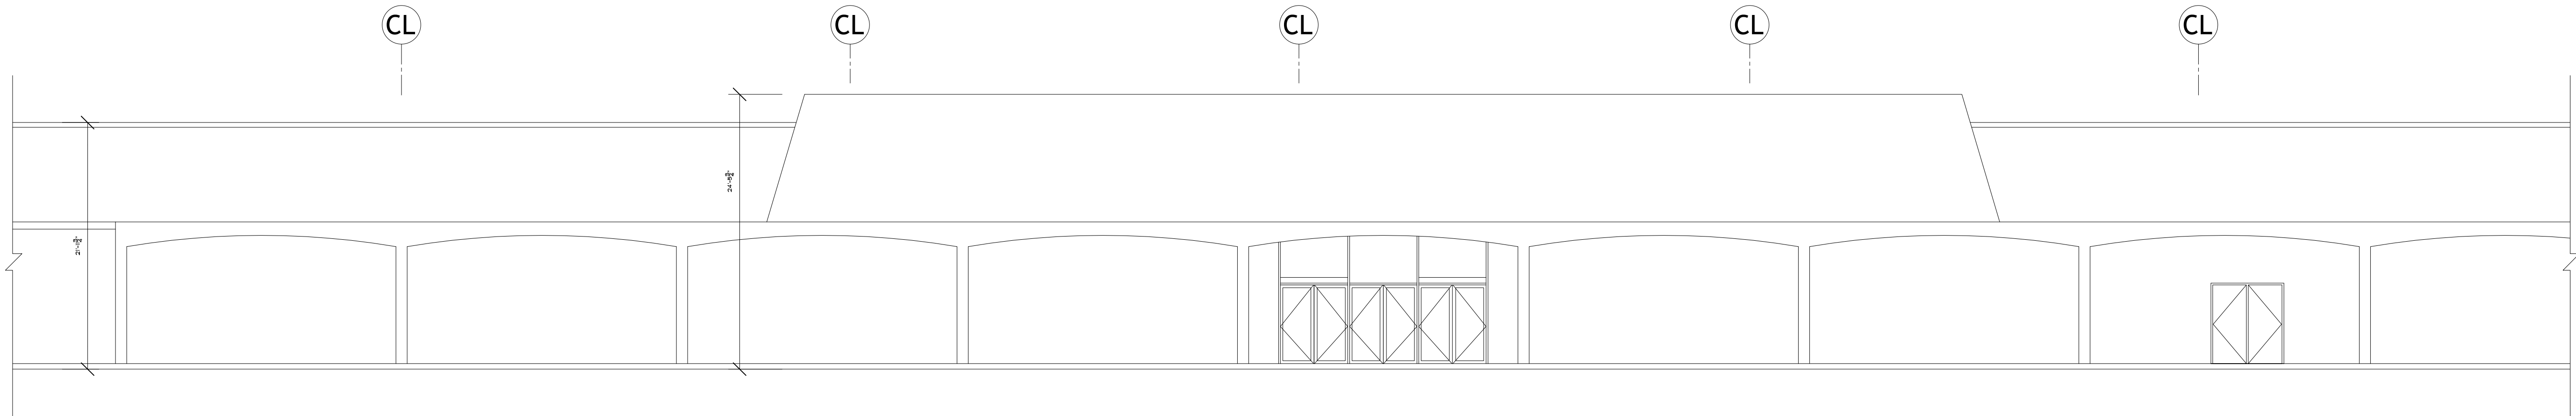

NORTH ELEVATION E3
SCALE: 1/8" = 1'-0"



NORTH ELEVATION E3
SCALE: 1/8" = 1'-0"

As BUILT

PROFESSIONALS

www.asbuiltprofessionals.com

A DIVISION OF:

AEC

CONSULTANTS INC

844.272.8458

844 AS BUILT

© 2020 AEC CONSULTANTS INC


ARCHITECTURAL AS BUILT

SUNRISE MOUNTAIN PLAZA


LAS VEGAS, NV 89110

01	100% SUBMISSION	DATE
NO.	ISSUES REVISIONS	DATE
SHEET TITLE		
EXTERIOR ELEVATIONS		
HL	PROJECT MANAGER	
HL	PROJECT DIRECTOR	
	PROJECT NUMBER	
1/8"=1'-0"	SCALE	
MM	DRAWN BY	
	SHEET NUMBER	

AB-11

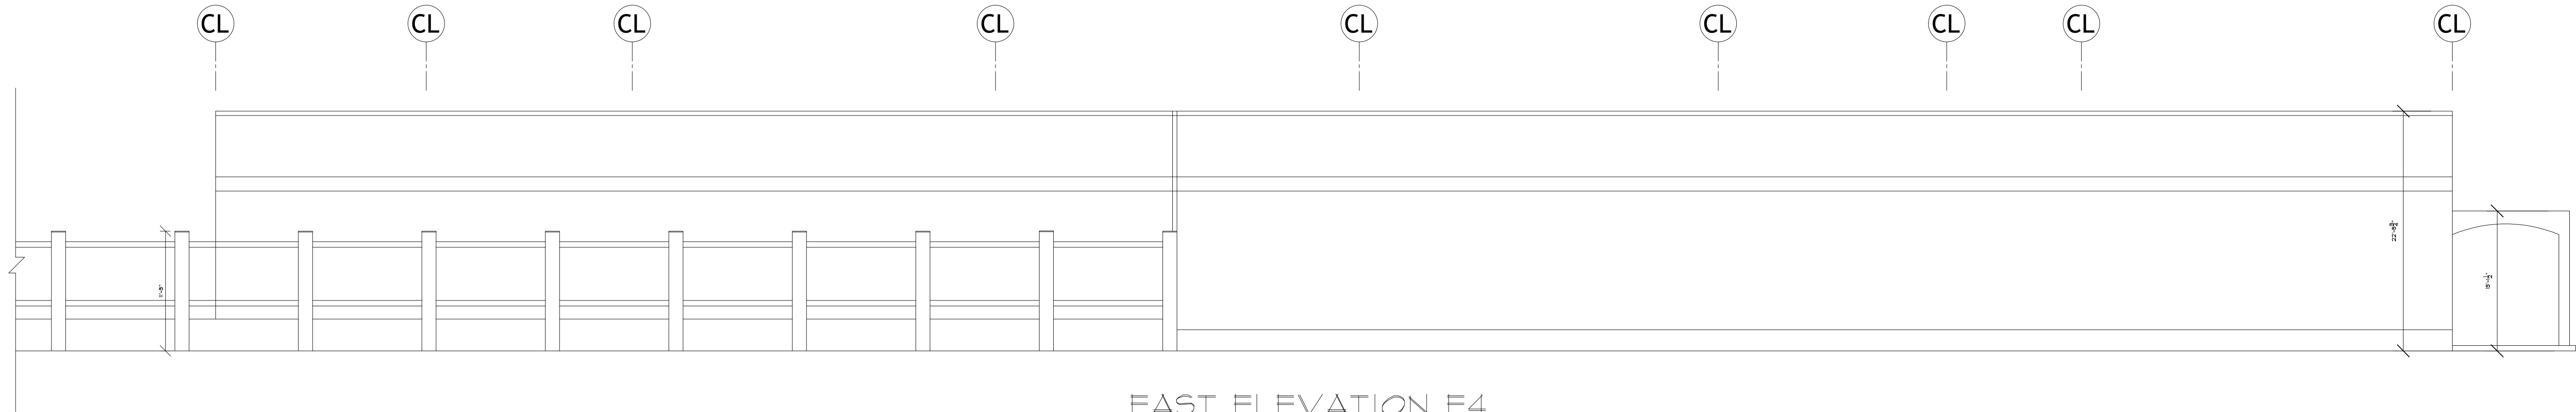

EAST ELEVATION E4
SCALE: 1/8" = 1'-0"

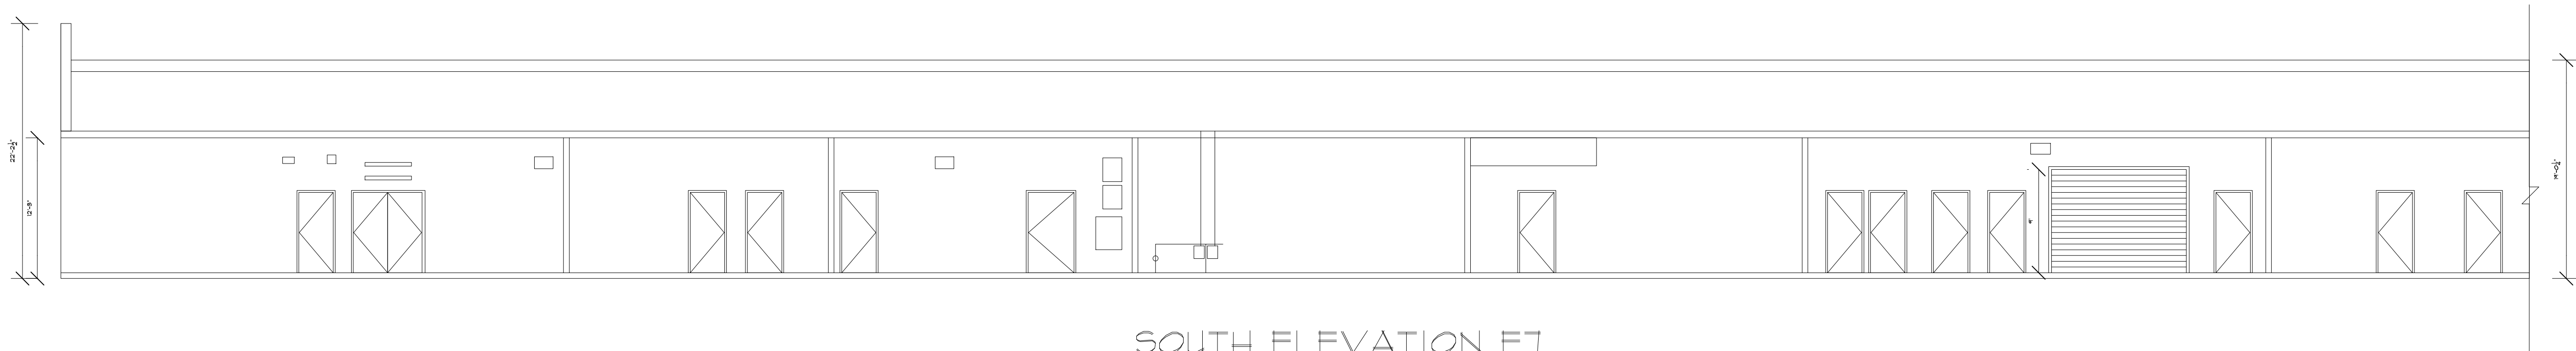

SOUTH ELEVATION E7
SCALE: 1/8" = 1'-0"



WEST ELEVATION E6
SCALE: 1/8" = 1'-0"

As BUILT

PROFESSIONALS

www.asbuiltprofessionals.com

A DIVISION OF:

AEC

CONSULTANTS INC

844.272.8458

844 ASBUILT

© 2020 AEC CONSULTANTS INC

ARCHITECTURAL AS BUILT

SUNRISE MOUNTAIN PLAZA

LAS VEGAS, NV 89110

01	100% SUBMISSION			
NO.	ISSUES REVISIONS	DATE		
SHEET TITLE				
EXTERIOR ELEVATIONS				
HL	PROJECT MANAGER			
HL	PROJECT DIRECTOR			
	PROJECT NUMBER			
1/8"=1'-0"	SCALE			
MM	DRAWN BY			
SHEET NUMBER				
AB-12				

As BUILT

PROFESSIONALS

www.asbuiltprofessionals.com

A DIVISION OF:

AEC

CONSULTANTS INC

844.272.8458

844 AS BUILT


© 2020 AEC CONSULTANTS INC

ARCHITECTURAL AS BUILT


SUNRISE MOUNTAIN PLAZA

LAS VEGAS, NV 89110


01	100% SUBMISSION	
NO.	ISSUES REVISIONS	DATE
SHEET TITLE		
EXTERIOR ELEVATIONS		
HL	PROJECT MANAGER	
HL	PROJECT DIRECTOR	
	PROJECT NUMBER	
1/8"=1'-0"	SCALE	
MM	DRAWN BY	
	SHEET NUMBER	
AB-13		

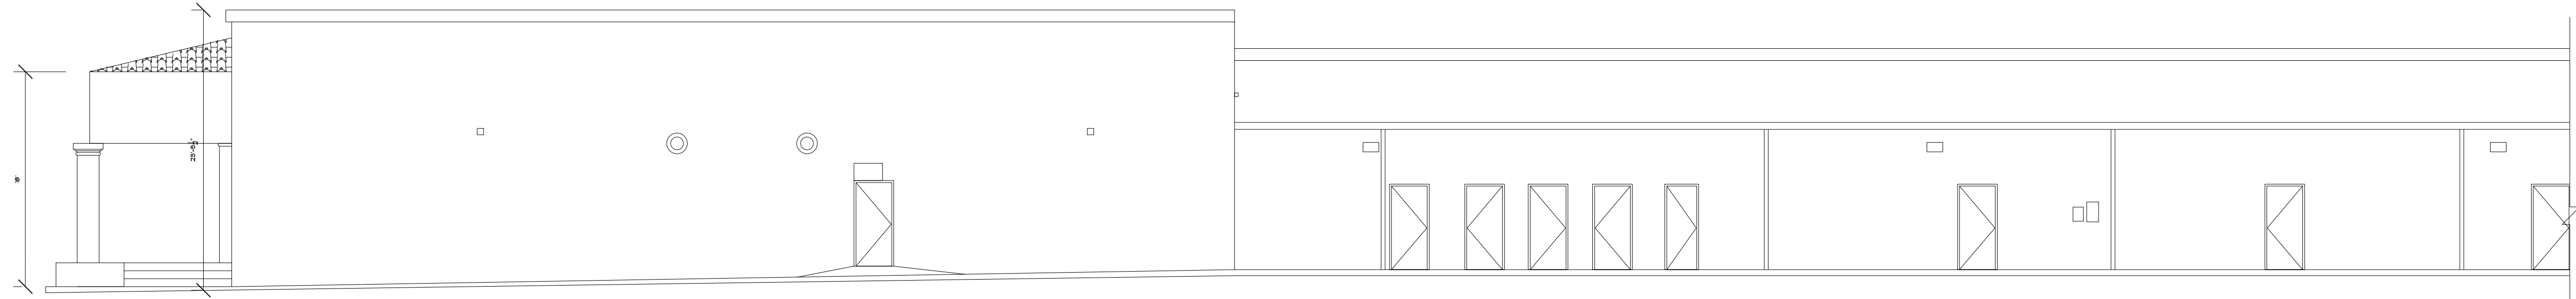

WEST ELEVATION E8
SCALE: 1/8" = 1'-0"

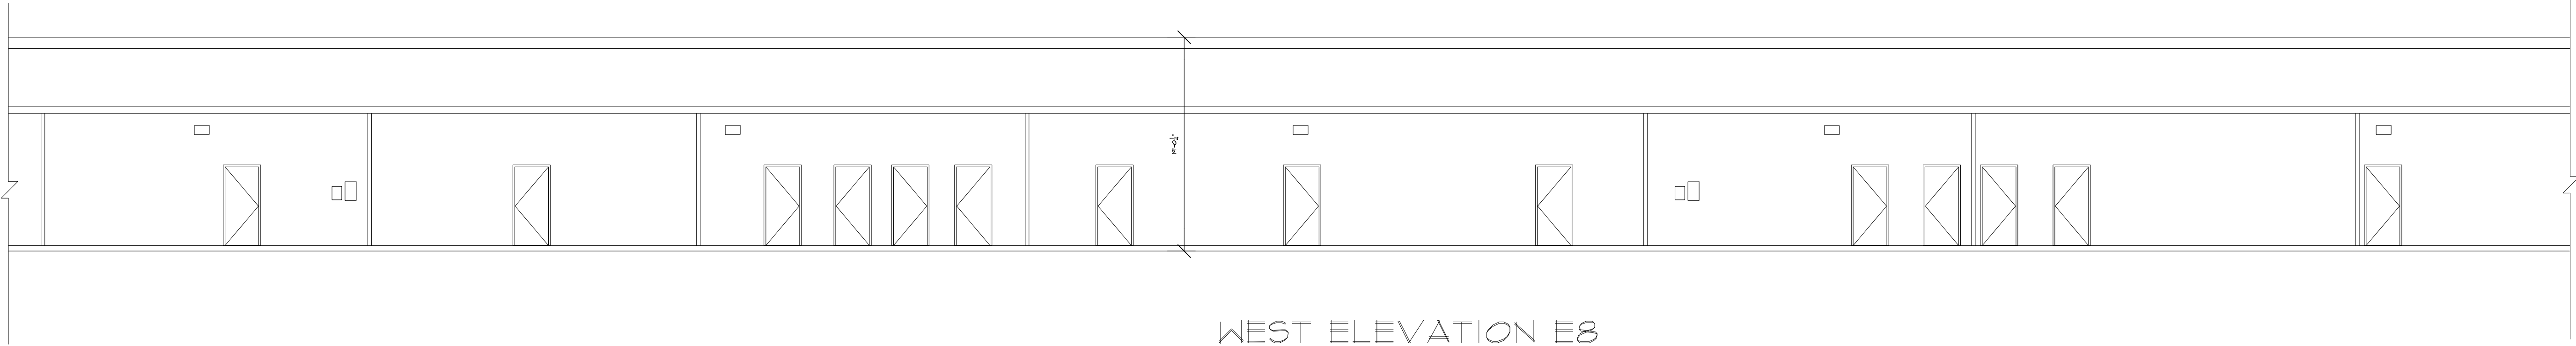

WEST ELEVATION E8
SCALE: 1/8" = 1'-0"

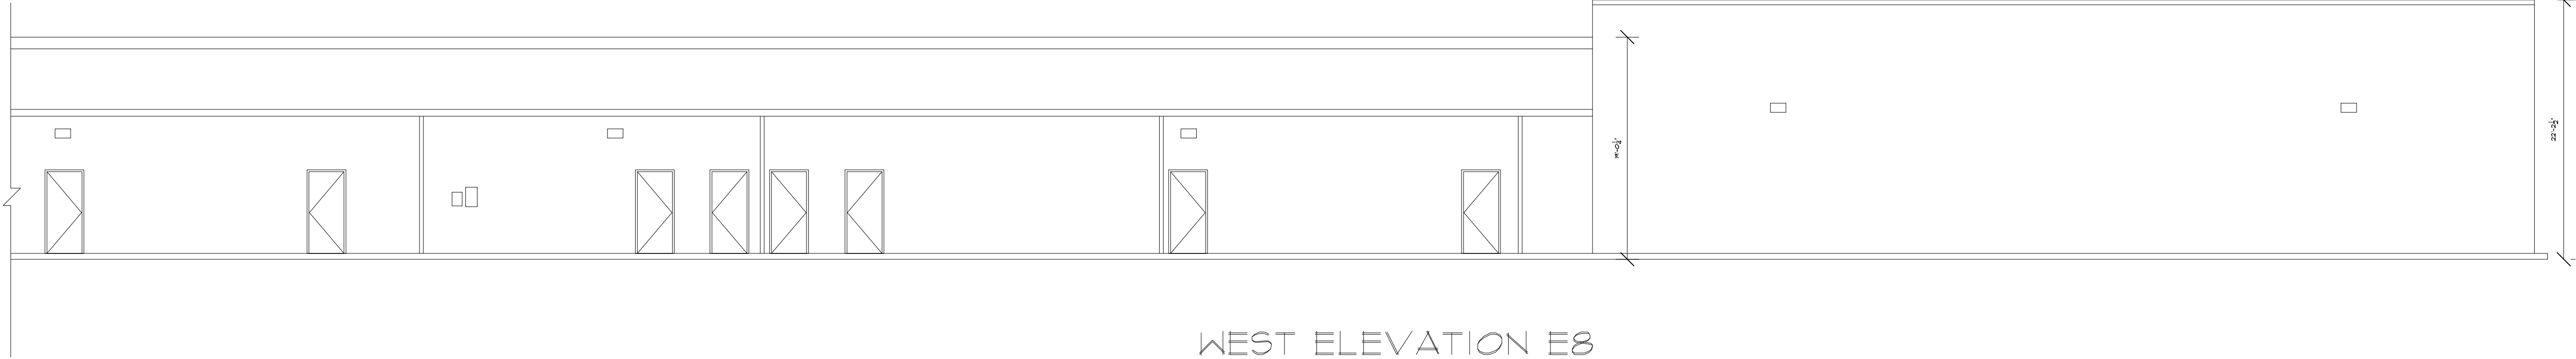

WEST ELEVATION E8
SCALE: 1/8" = 1'-0"

As BUILT

PROFESSIONALS

www.asbuiltprofessionals.com

A DIVISION OF:

AEC

CONSULTANTS INC

844.272.8458

844 AS BUILT

© 2020 AEC CONSULTANTS INC

ARCHITECTURAL AS BUILT
SUNRISE MOUNTAIN PLAZA
LAS VEGAS, NV 89110

01	100% SUBMISSION	
NO.	ISSUES REVISIONS	DATE
SHEET TITLE		
EXTERIOR ELEVATIONS		
HL	PROJECT MANAGER	
HL	PROJECT DIRECTOR	
	PROJECT NUMBER	
	SCALE	
1/8"=1'-0"	DRAWN BY	
MM	SHEET NUMBER	
AB-14		