


SANTA BARBARA, CA 93018

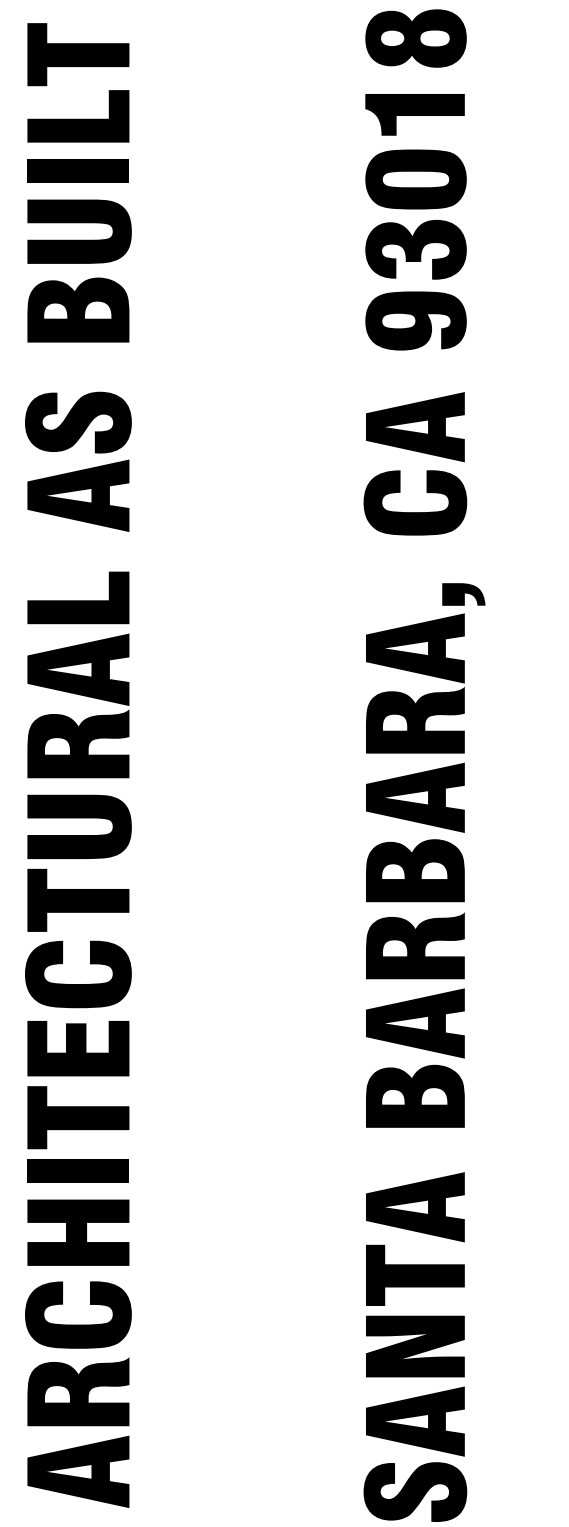

<u>GROSS AREA DATA</u>	
BASEMENT	1,485 S.F.
FIRST FLOOR	5,304 S.F.
MEZZANINE	105 S.F.
ATTIC	3,445 S.F.
GRAND TOTAL	10,339 S.F.



C-1

SYMBOLS LEGEND

RCP

	EXHAUST VENT		TRACK LIGHT OR VANITY LIGHT
	CEILING MOUNTED LIGHT FIXTURE		WALL-MOUNTED LIGHT FIXTURE
	CEILING MOUNTED DIRECTIONAL LIGHT		EMERGENCY EXIT SIGN
	RECESSED CAN LIGHT		EMERGENCY EXIT LIGHT
	EYEBALL OR SMALL CAN LIGHT		EMERGENCY EXIT LIGHT W/ SIGN
	PENDANT LIGHT		LIGHTED STAIR SIGN
	INDIVIDUAL FLUOR. LAY-IN FIXTURE 4 BULB		FLOOD LIGHT
	INDIVIDUAL FLUOR. HANGING FIXTURE 2 BULB		PHOTO CELL
	INDIVIDUAL FLUOR. FLUSH MOUNT FIXTURE 4 BULB		CEILING FAN
	CAMERA		CEILING FAN W/ LIGHT KIT
	MOTION DET.		7-2-6 CEILING HEIGHT AND TRIM 7'-2" ABOVE FLOOR BELOW WITH 6" CROWN MOULDING. NOTE: ALL CEILINGS NOT LABELED ARE PLASTER. CEILINGS SHOWN WITH A GRID ARE LAY IN ACOUSTICAL TILE..
	SUPPLY VENT		JUNCTION BOX
	SUPPLY VENT		
	RETURN VENT		
	RETURN VENT		
	SPEAKER		

ELECTRIC

	DATA OUTLET
	TELEPHONE JACK
	ELECTRIC SWITCH
	CABLE TELEVISION OUTLET
	DUPLEX RECEPTACLE OUTLET
	SPECIAL PURPOSE CONNECTION OR OUTLET
	QUADRUPLUX RECEPTACLE OUTLET
	FLOOR DUPLEX RECEPTACLE OUTLET
	ELECTRIC PANEL
	ELECTRIC METER
	BUTTON SWITCH
	DISCONNECT SWITCH
	GROUND/FLOOR LIGHT
	KEY PAD

FIRE PROTECTION


	FIRE EXTINGUISHER
	FIRE PULL
	FIRE ALARM (HORN/SRTOBE)
	SMOKE DETECTOR
	SMOKE ALARM SPEAKER
	SPRINKLER HEAD CEILING MOUNT
	SPRINKLER HEAD WALL MOUNT

MEP


	THERMOSTAT
	FLOOR DRAIN
	VALVE
	HOSE BIB
	WATER SUPPLY
	SUSPENDED GAS HEATER

MISC

	BOLLARD
	SPOT ELEVATION

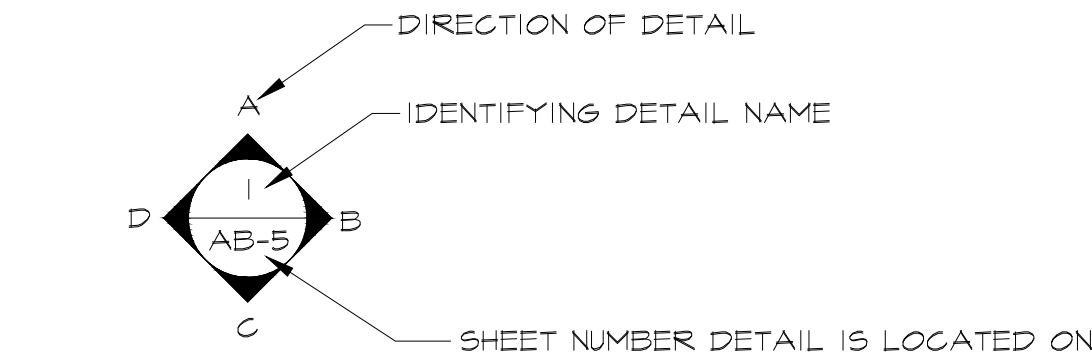

INTERIOR ELEVATIONS

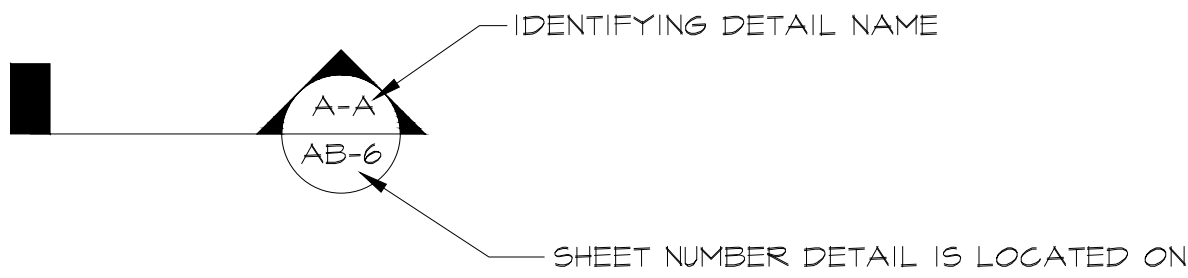

BUILDING SECTION

PHOTO DOCUMENTATION LEGEND

INDICATES LOCATION OF CAMERA


INDICATES DIRECTION OF CAMERA LENS AND CORRESPONDING PHOTO / VIDEO NUMBER

TYPES OF DOCUMENTATION

	GROUND BASED PHOTO		GROUND BASED VIDEO		360° SPHERICAL PHOTO		AERIAL BASED PHOTO		AERIAL BASED VIDEO
--	--------------------	--	--------------------	--	----------------------	--	--------------------	--	--------------------

ARCHITECTURAL AS BUILT
SANTA BARBARA, CA 93018

01	100% SUBMISSION	SEE COVER SHEET
NO.	ISSUES REVISIONS	DATE
		SHEET TITLE
HL	PROJECT MANAGER	
HL	PROJECT DIRECTOR	
012317-1	PROJECT NUMBER	
NOT TO SCALE		SCALE
CL	DRAWN BY	
		SHEET NUMBER

 


ARCHITECTURAL AS BUILT


SANTA BARBARA, CA 93018

FIRST FLOOR PLAN

AB-1

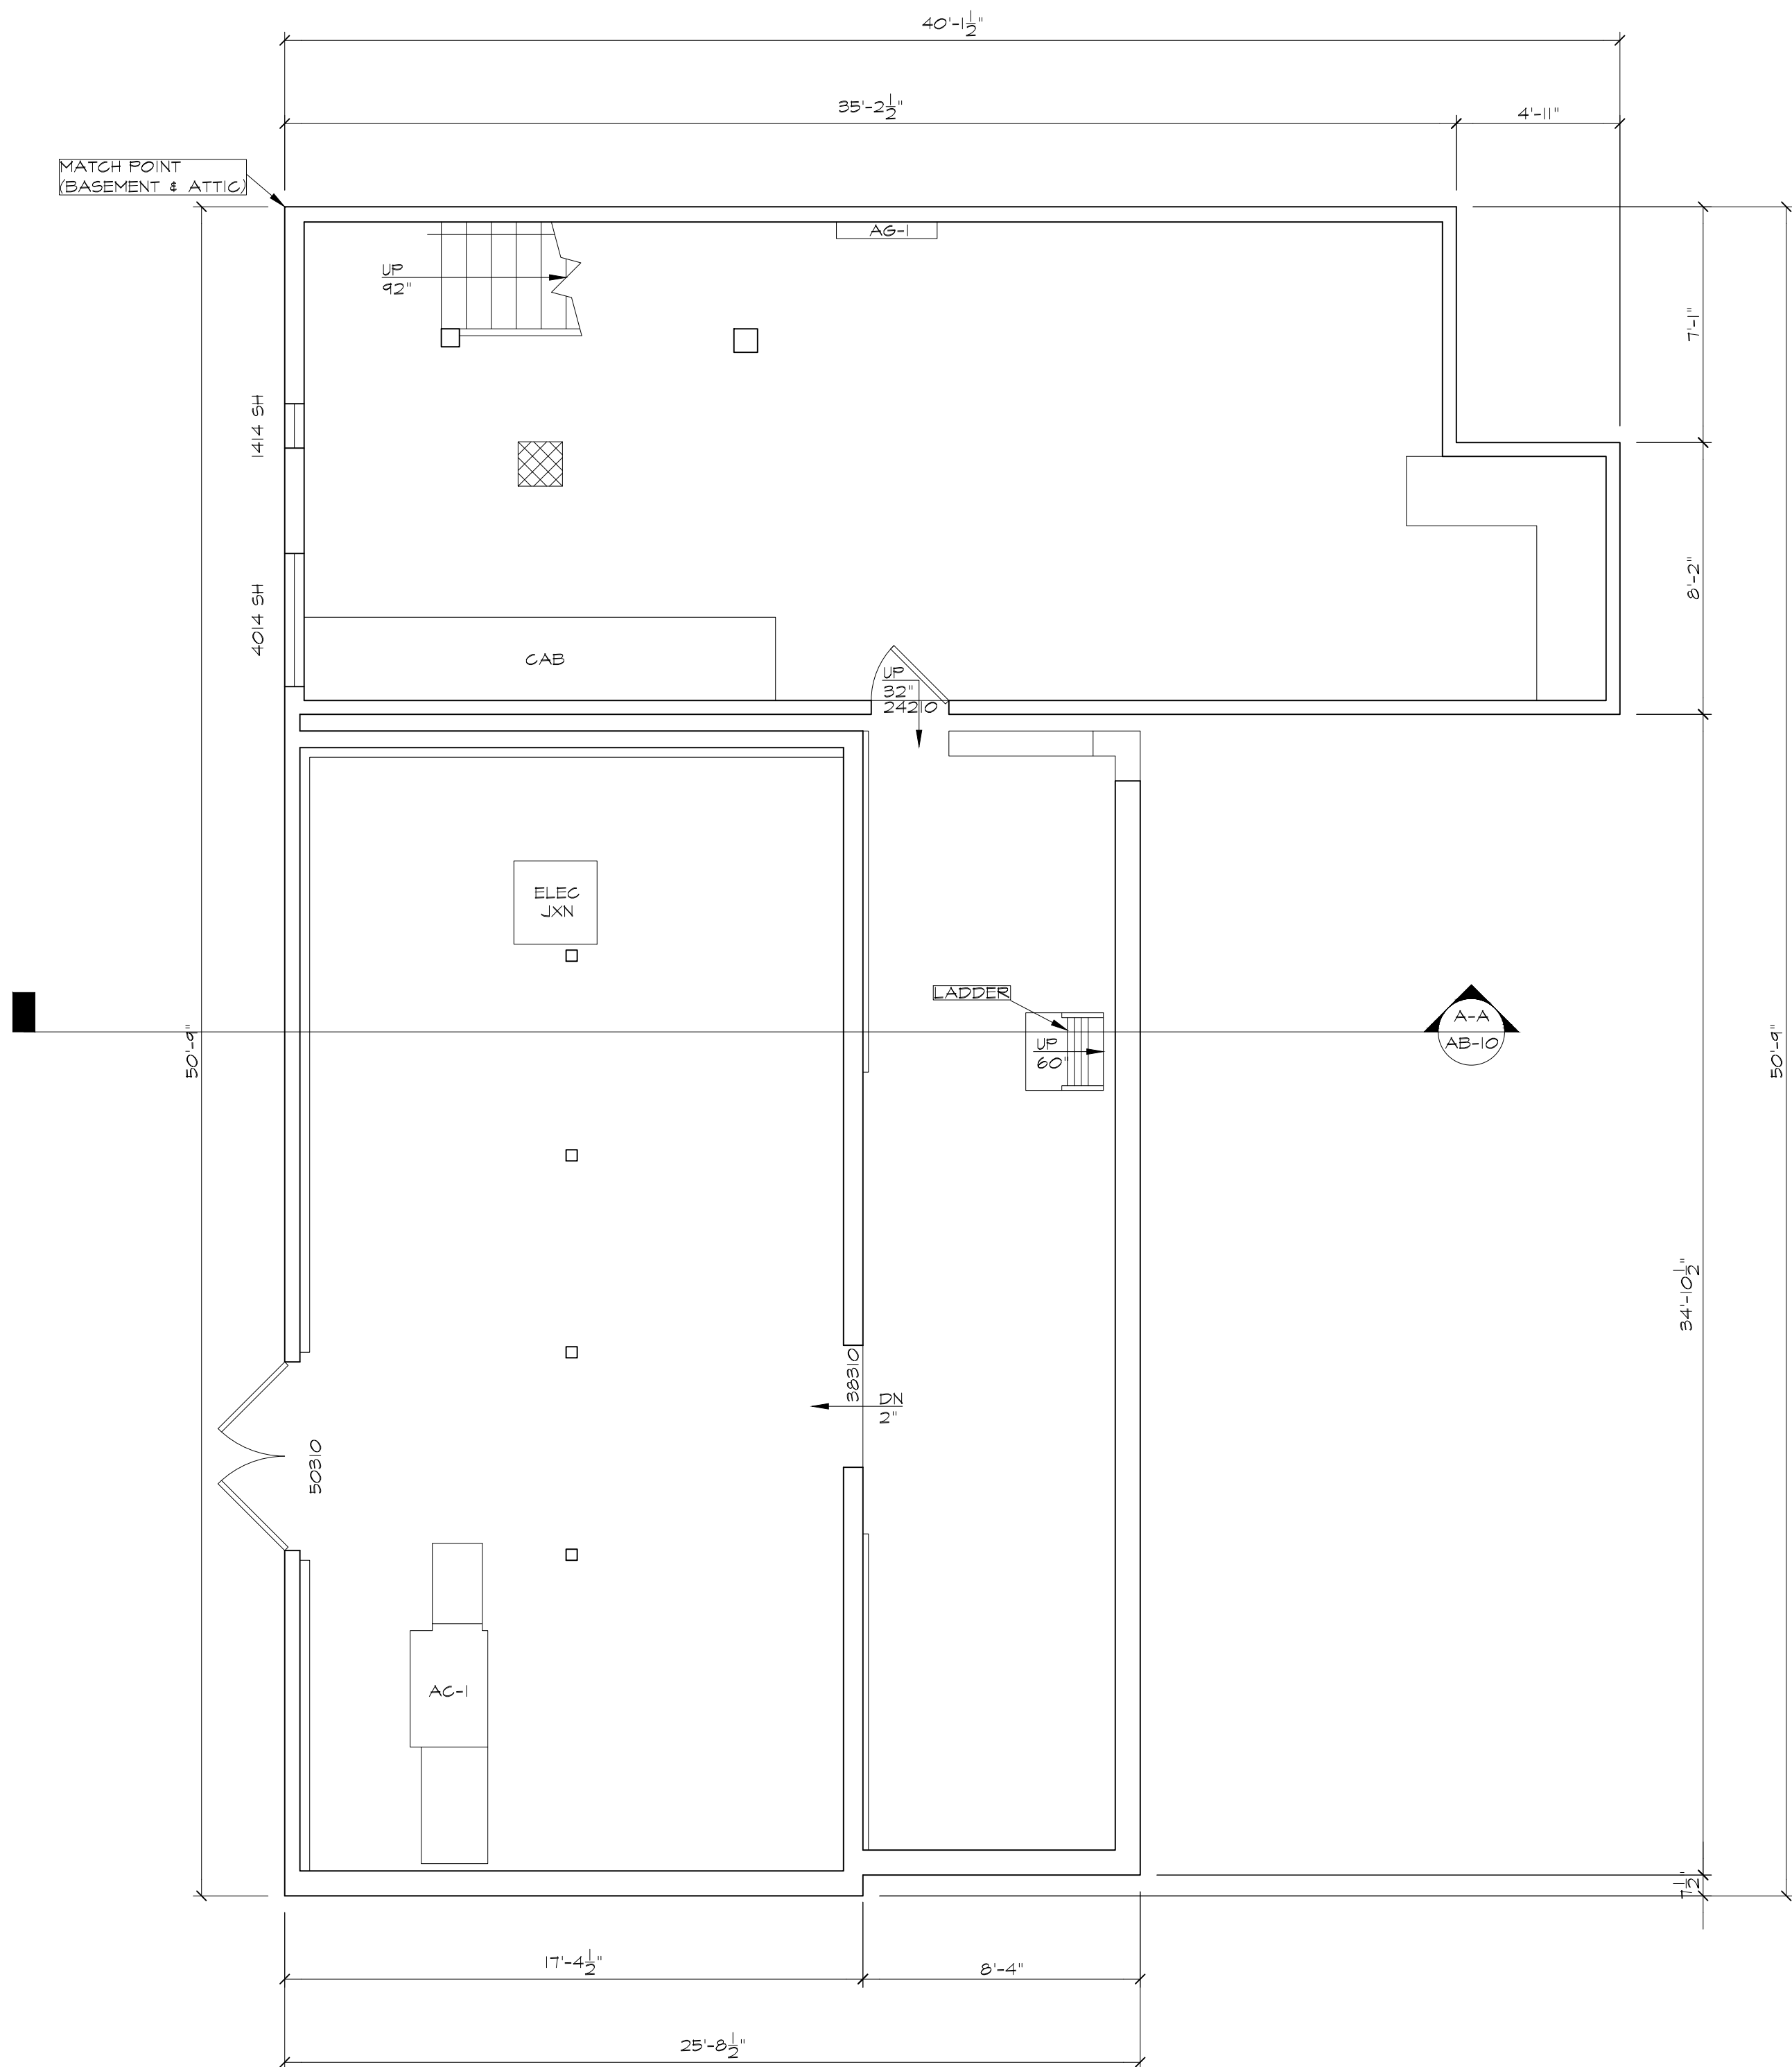

BASEMENT PLAN 1/4"=1'-0"

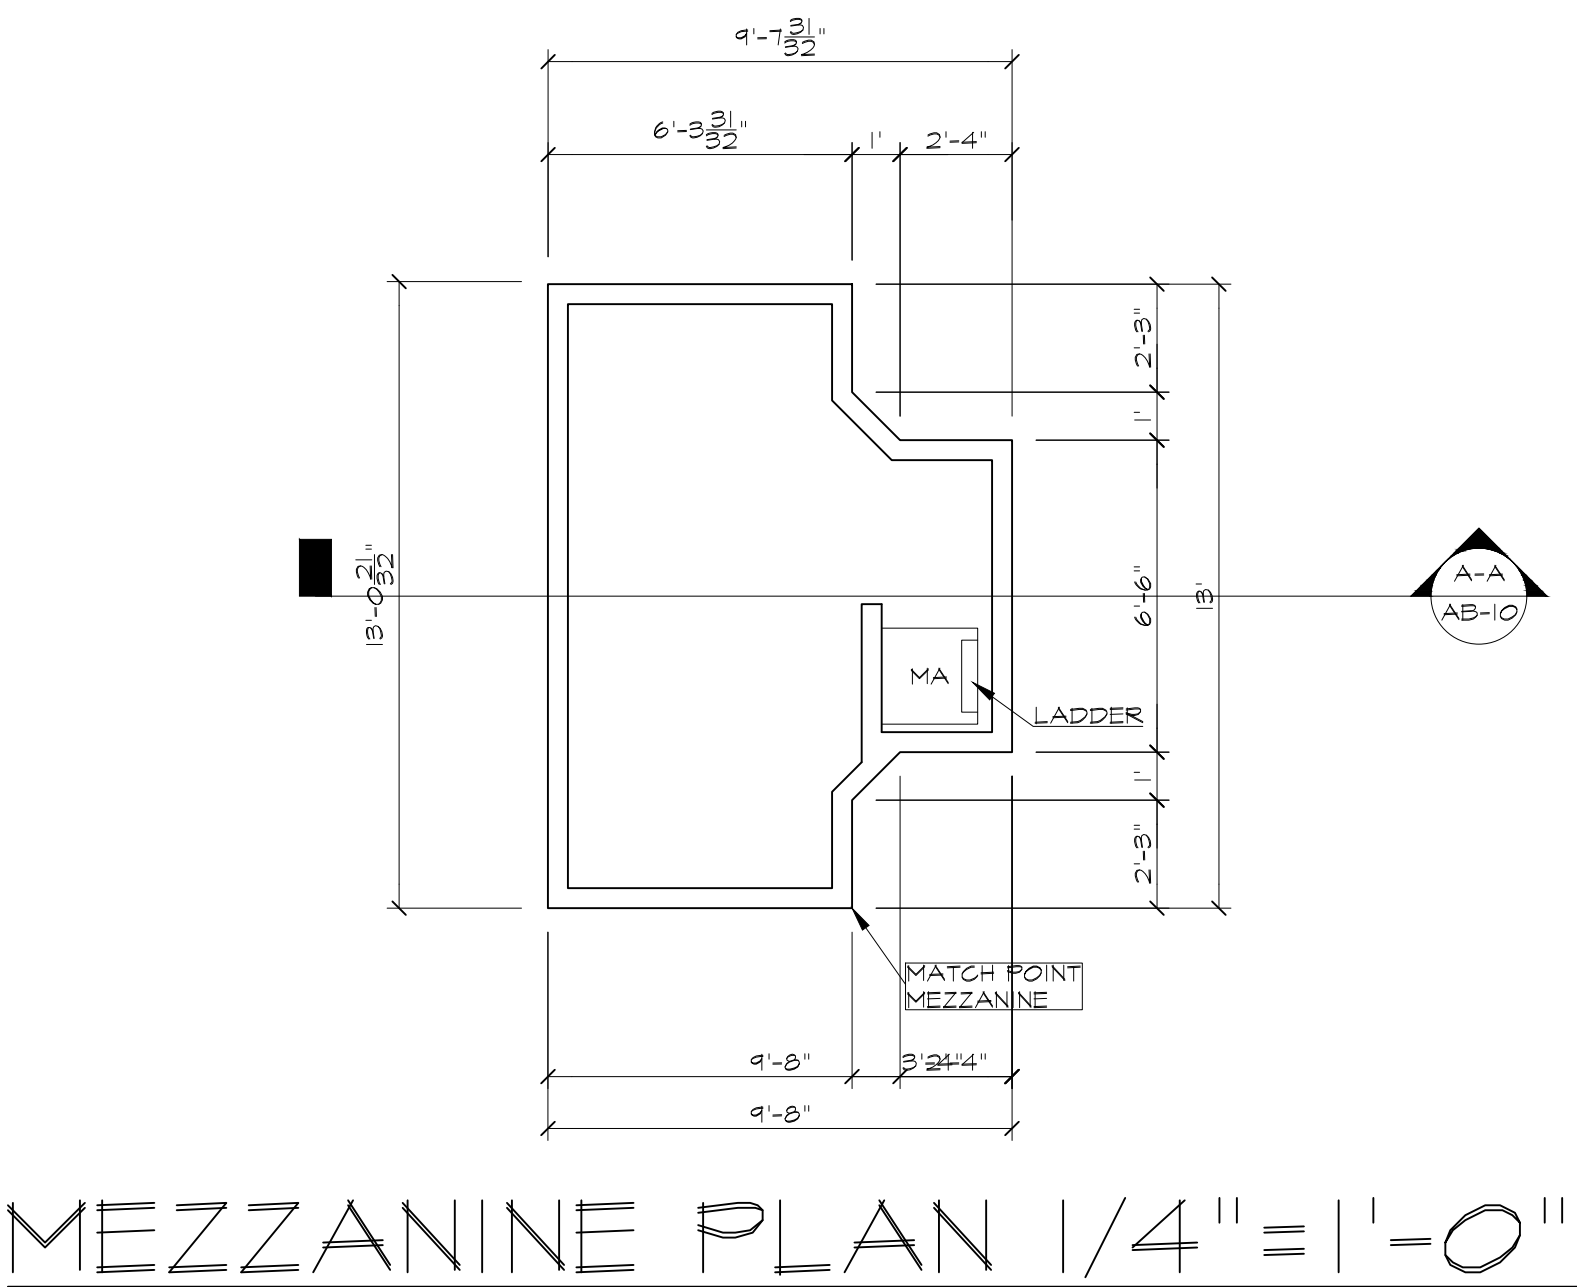

MEZZANINE PLAN 1/4"=1'-0"

ARCHITECTURAL AS BUILT
SANTA BARBARA, CA 93018

01	100% SUBMISSION	SEE COVER SHEET
NO.	ISSUES REVISIONS	DATE

SHEET TITLE


**BASEMENT &
MEZZANINE PLAN**

HL	PROJECT MANAGER
HL	PROJECT DIRECTOR
012317-1	PROJECT NUMBER
1/4"=1'-0"	SCALE
CL	DRAWN BY

SHEET NUMBER


AB-2

ARCHITECTURAL AS BUILT
SANTA BARBARA, CA 93018

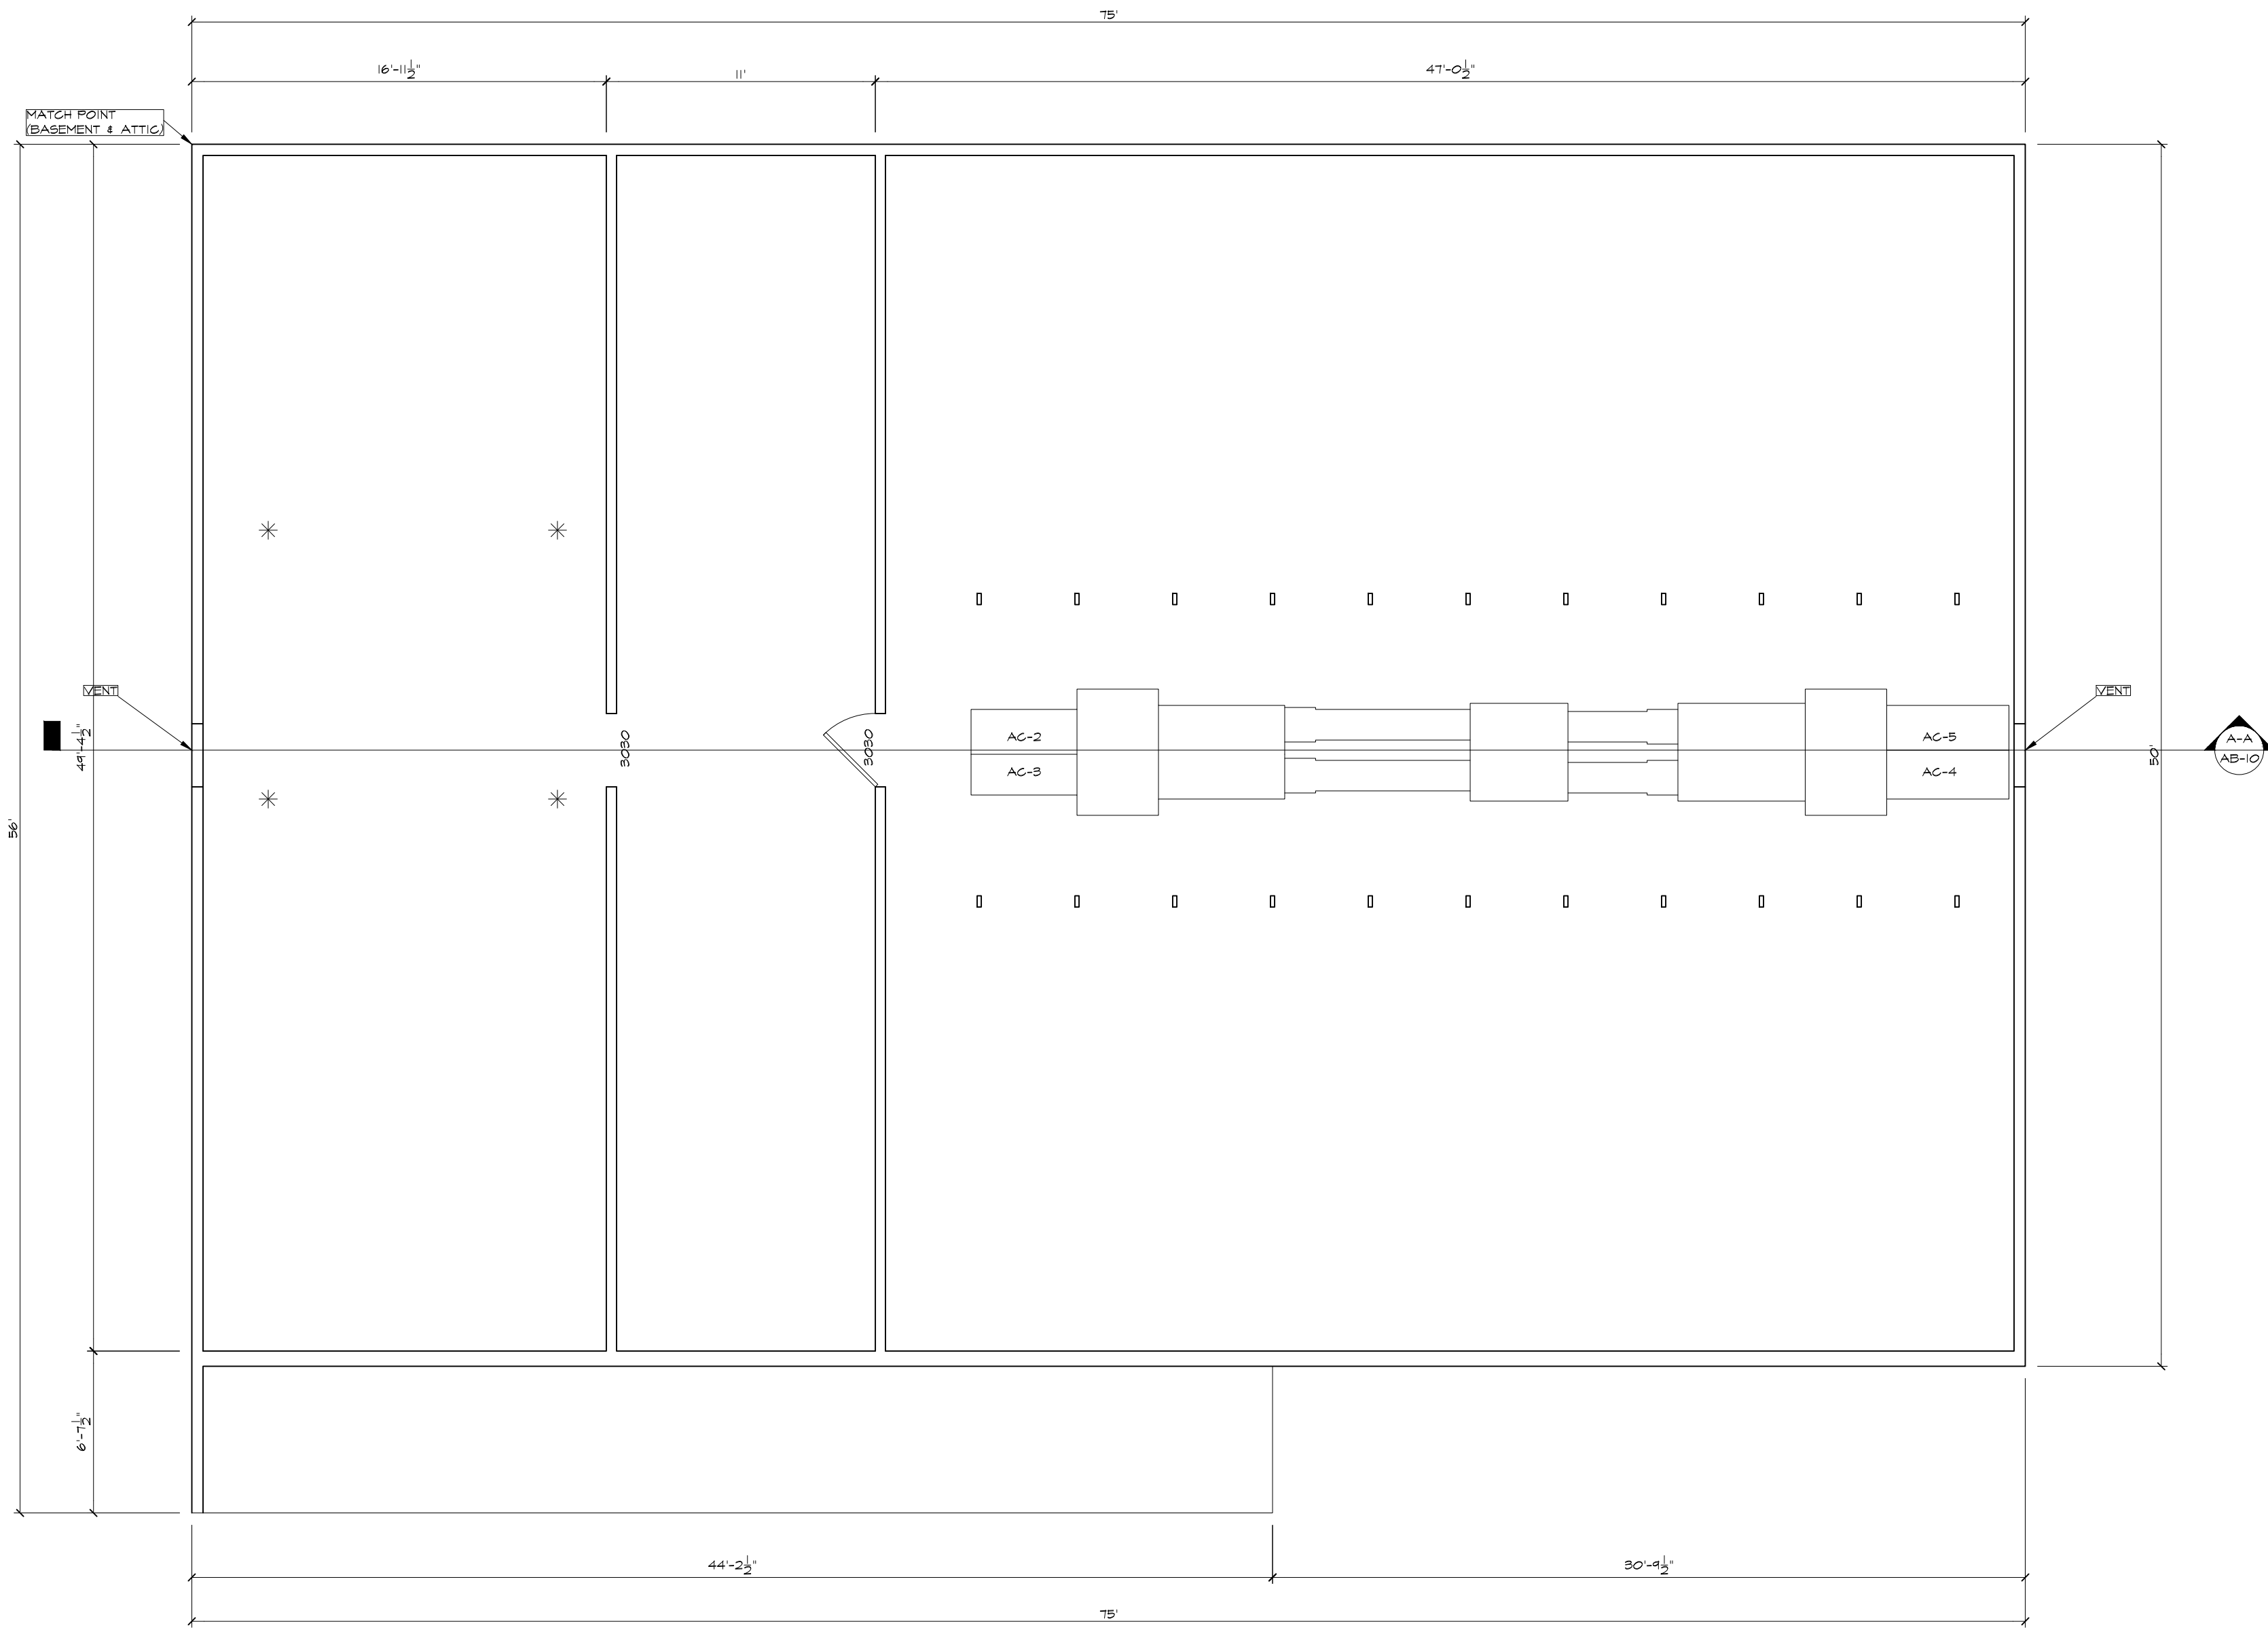

ATTIC PLAN 1/4"=1'-0"

01	100% SUBMISSION	SEE COVER SHEET
NO.	ISSUES REVISIONS	DATE
		SHEET TITLE
ATTIC PLAN		
HL	PROJECT MANAGER	
HL	PROJECT DIRECTOR	
012317-1	PROJECT NUMBER	
1/4"=1'-0"		SCALE
CL	DRAWN BY	
		SHEET NUMBER

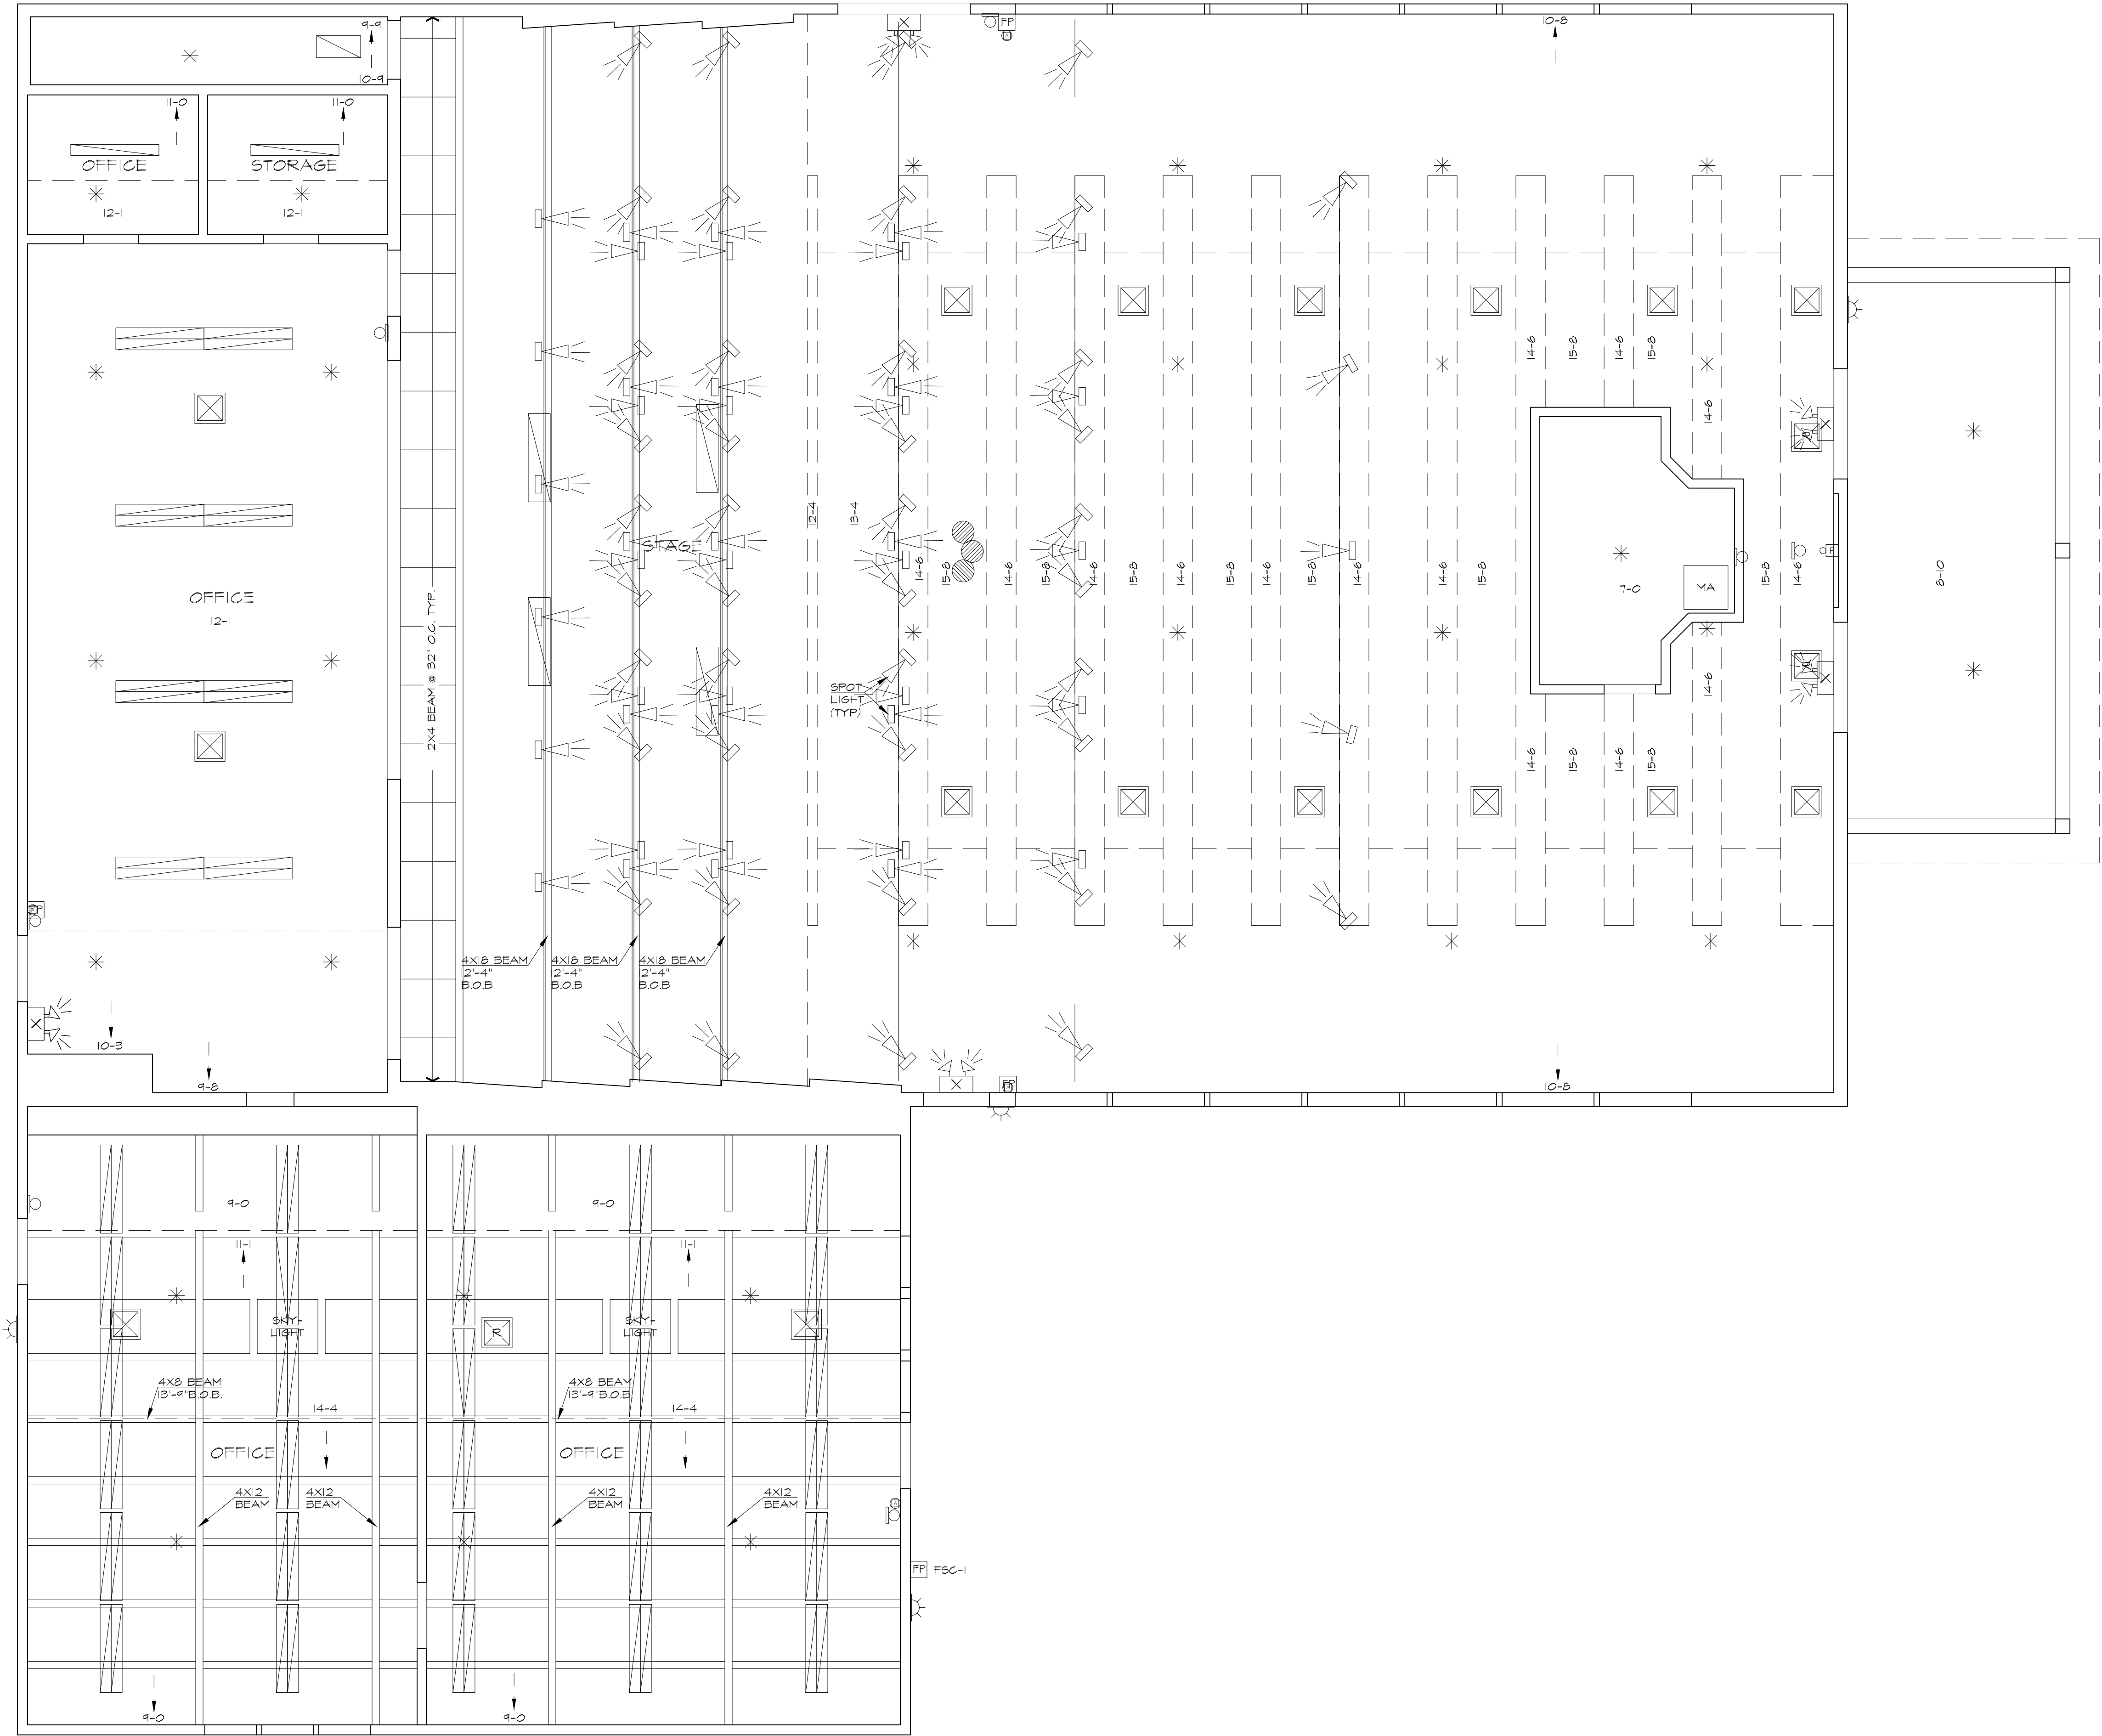

1ST FLOOR 1/4"=1'-0"



© 2020 AEC CONSULTANTS INC


ARCHITECTURAL AS BUILT
SANTA BARBARA, CA 93018

01	100% SUBMISSION	SEE COVER SHEET
NO.	ISSUES REVISIONS	DATE


FIRST FLOOR RCP

HL	PROJECT MANAGER
HL	PROJECT DIRECTOR
012317-1	PROJECT NUMBER
1/4"=1'-0"	SCALE
CL	DRAWN BY
	SHEET NUMBER

AB-4

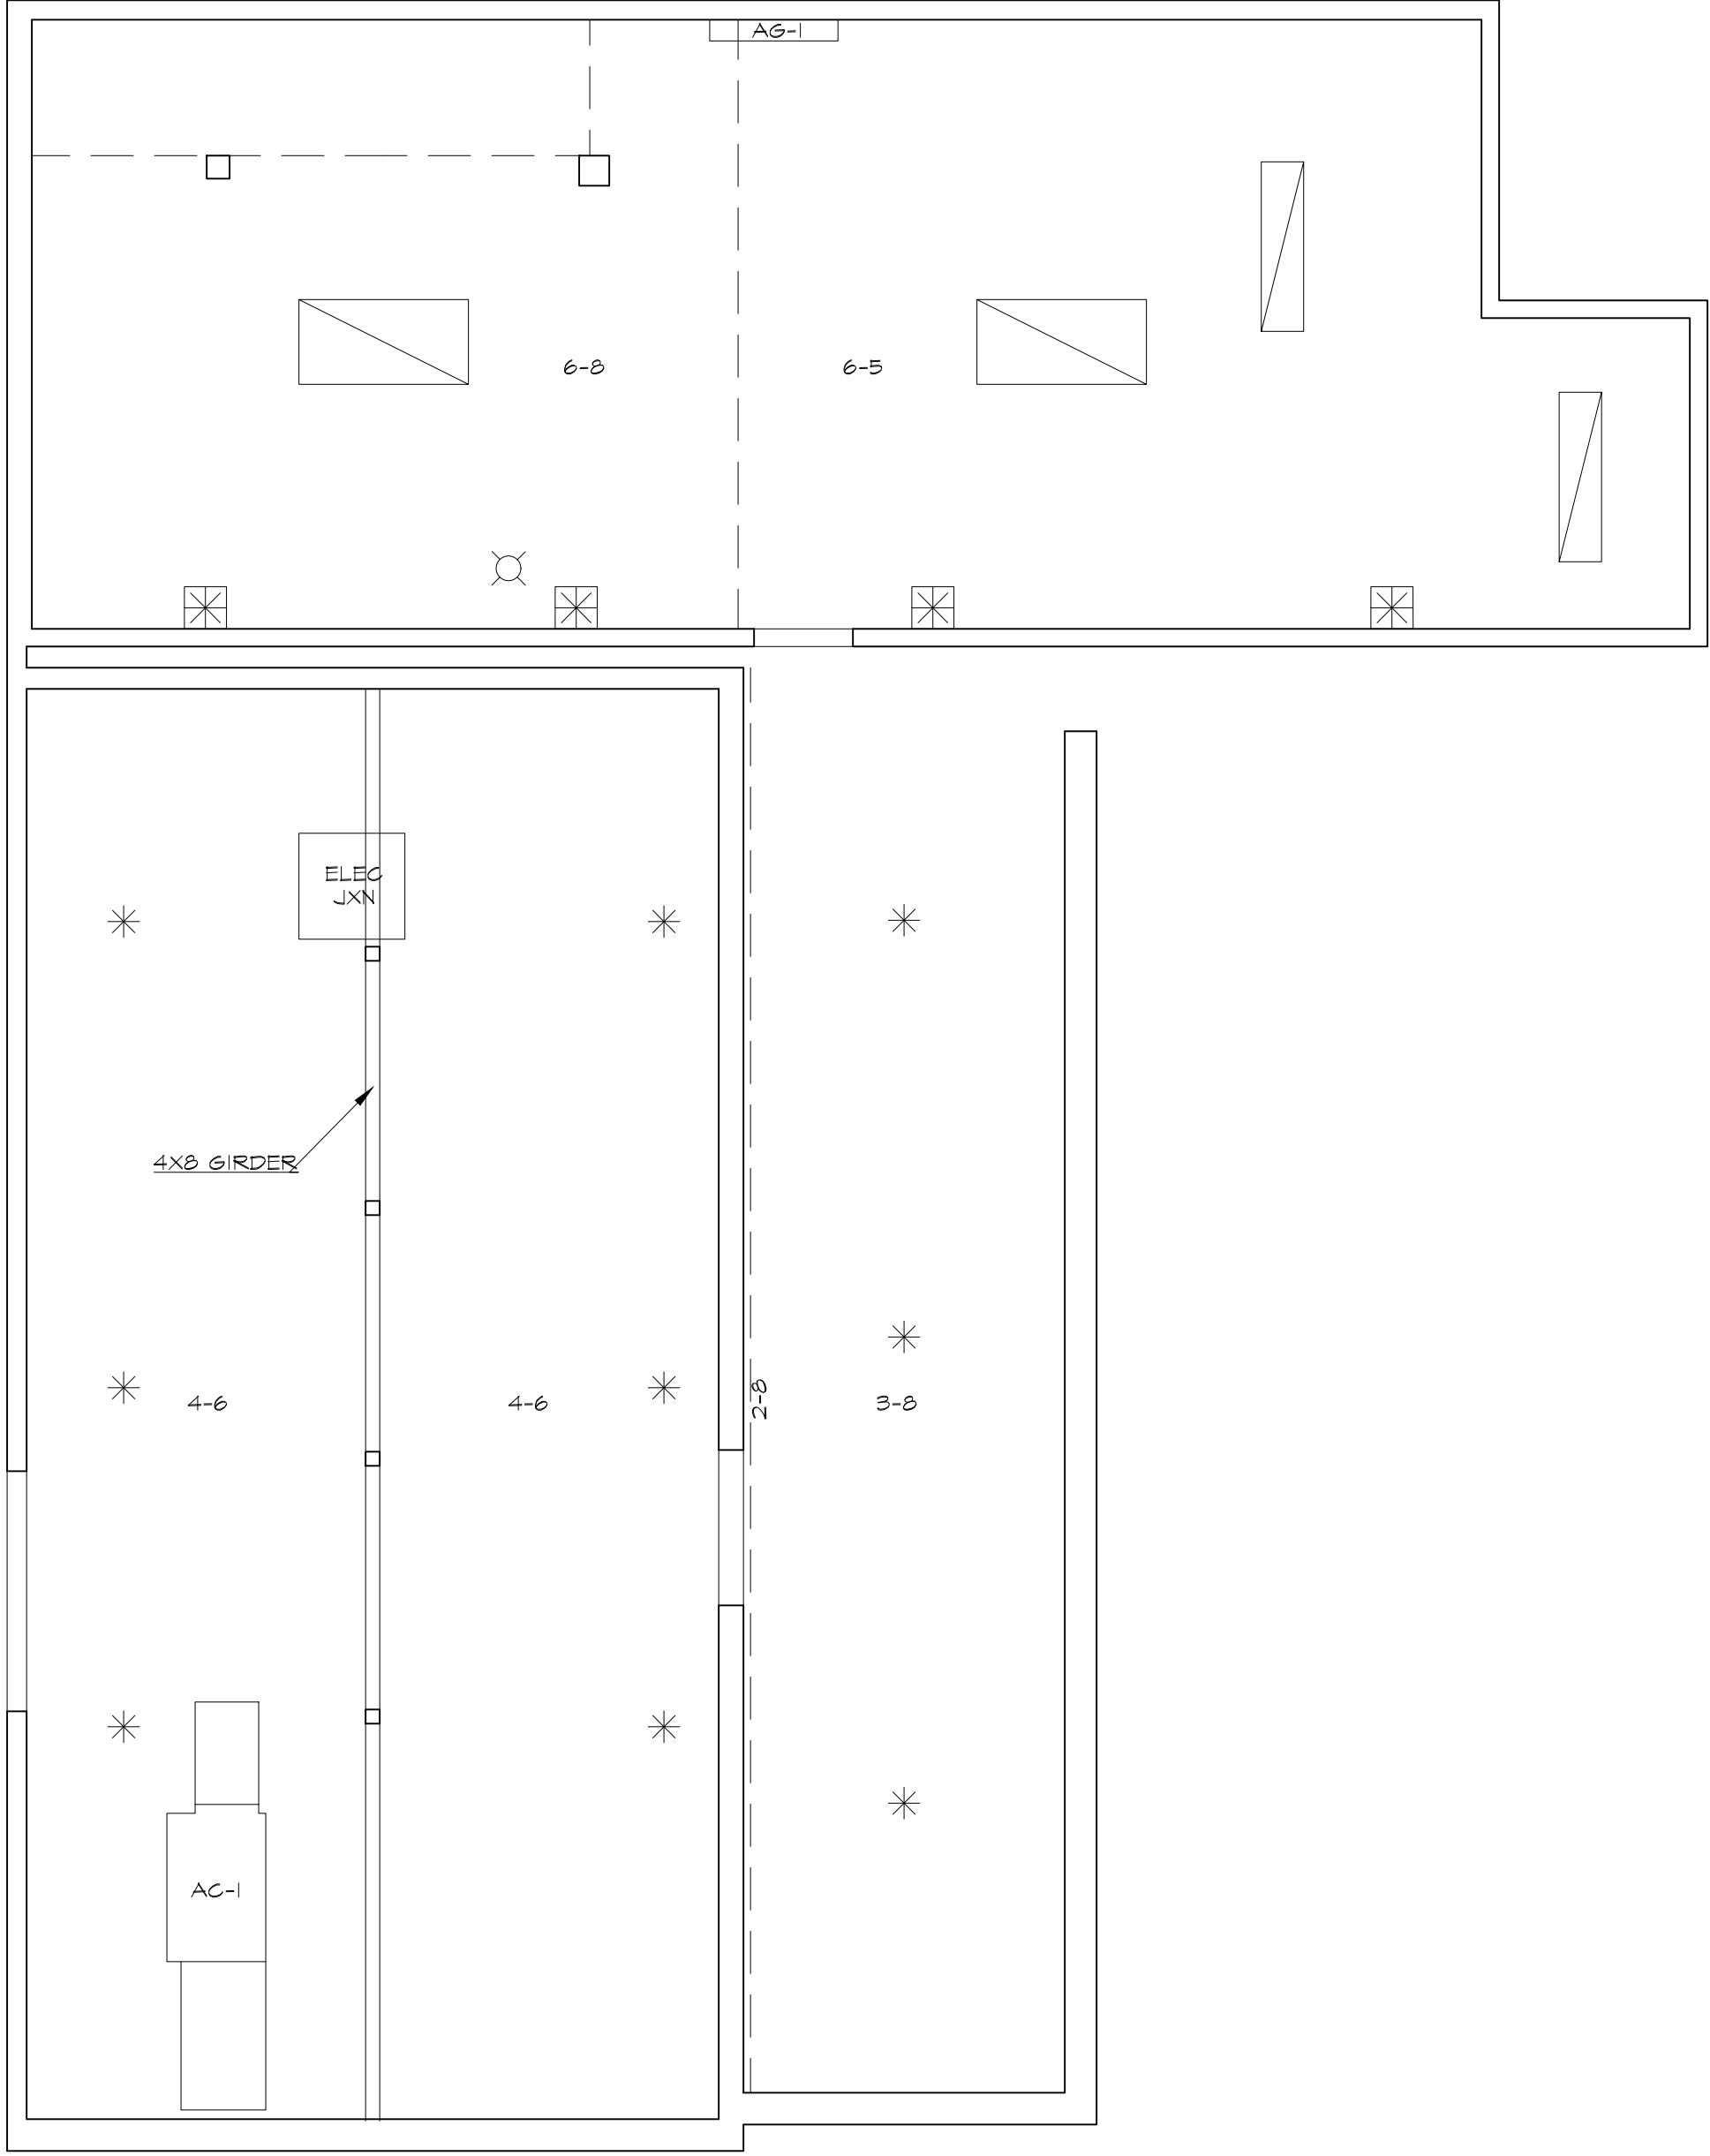

BASEMENT PLAN 1/4"=1'-0"

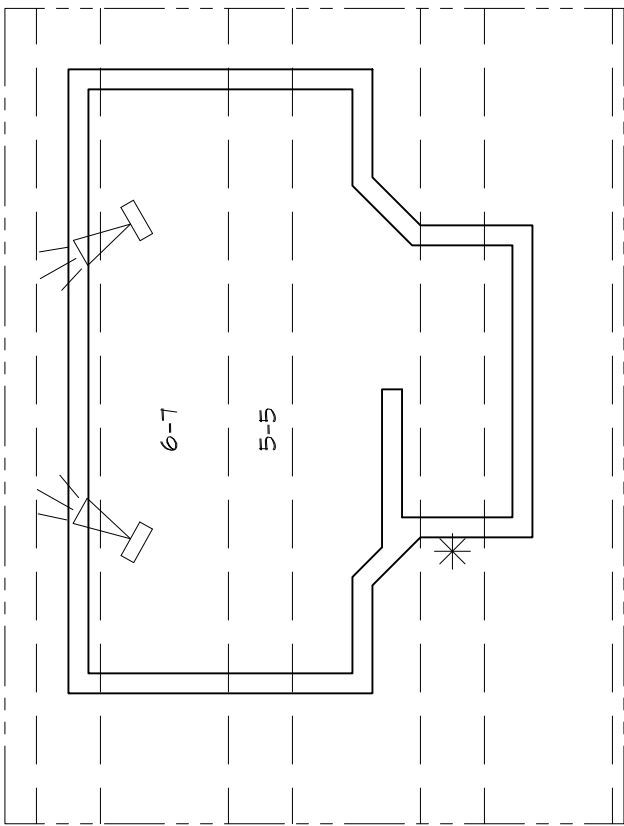

MEZZANINE PLAN 1/4"=1'-0"

ARCHITECTURAL AS BUILT
SANTA BARBARA, CA 93018

01	100% SUBMISSION	SEE COVER SHEET
NO.	ISSUES REVISIONS	DATE
		SHEET TITLE
BASEMENT & MEZZANINE RCP		
HL	PROJECT MANAGER	
HL	PROJECT DIRECTOR	
012317-1	PROJECT NUMBER	
1/4"=1'-0"	SCALE	
CL	DRAWN BY	
		SHEET NUMBER



ARCHITECTURAL AS BUILT

SANTA BARBARA, CA 93018

AB-6



AB-6



ARCHITECTURAL AS BUILT

SANTA BARBARA, CA 93018


AB-7

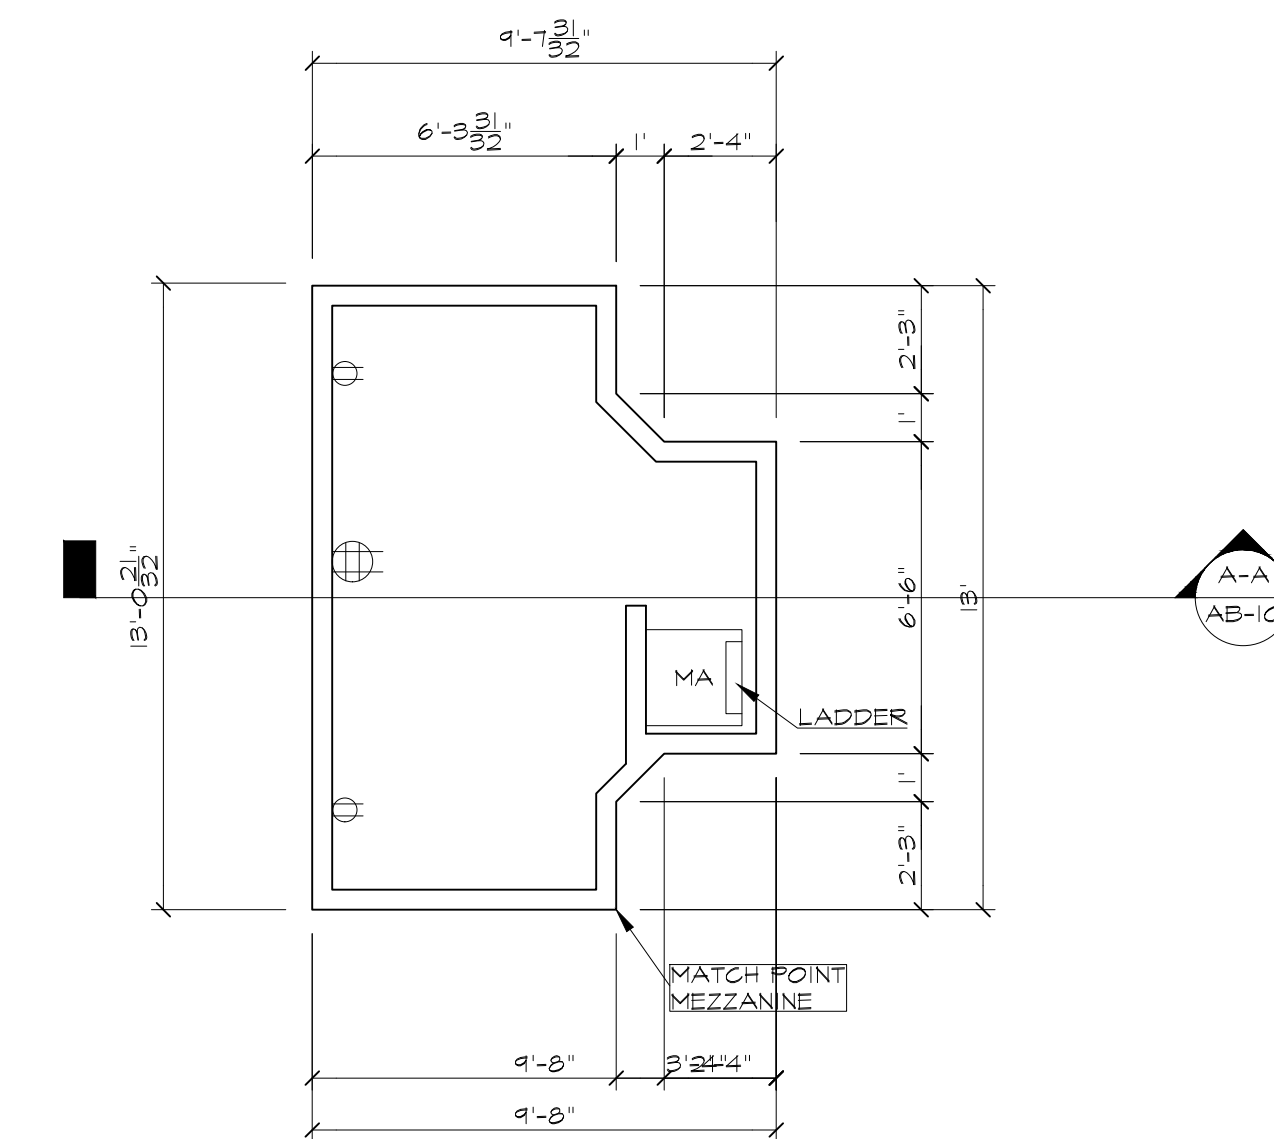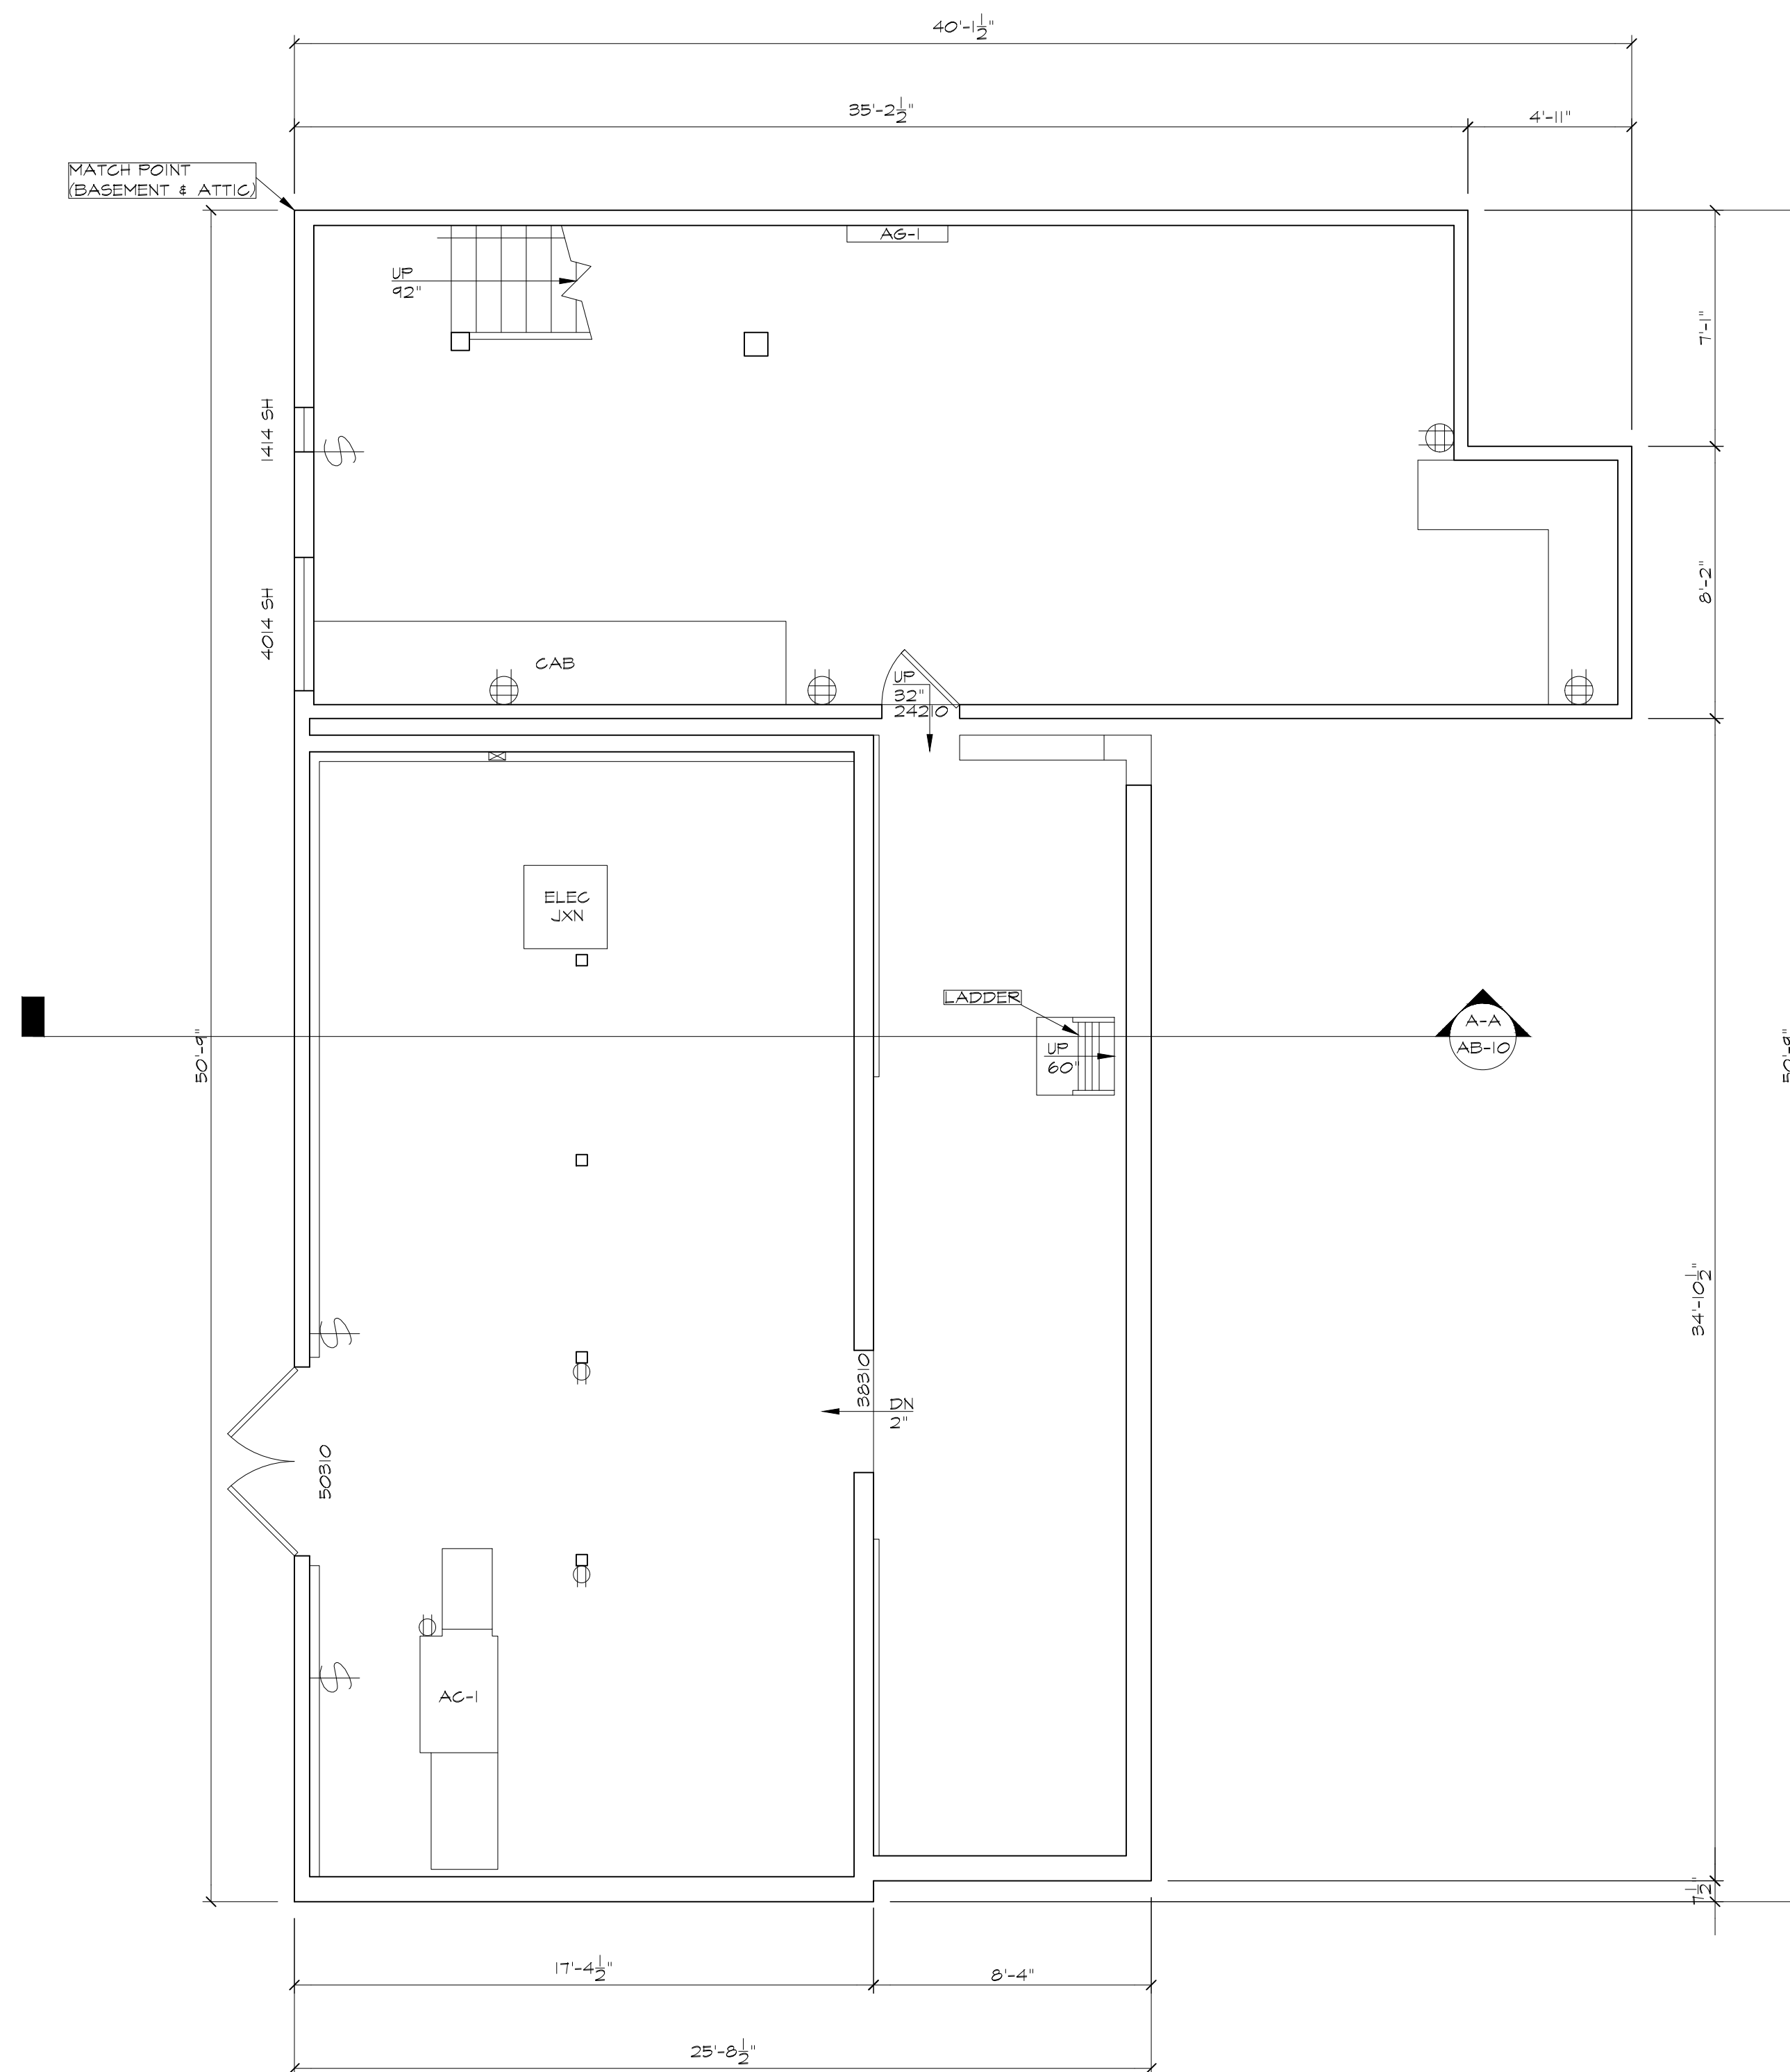

ARCHITECTURAL AS BUILT

SANTA BARBARA, CA 93018

01	100% SUBMISSION	SEE COVER SHEET
NO.	ISSUES REVISIONS	DATE
SHEET TITLE		
BASEMENT & MEZZANINE ELECTRICAL		
HL	PROJECT MANAGER	
HL	PROJECT DIRECTOR	
012317-1	PROJECT NUMBER	
SCALE		
1/4"=1'-0"		
CL	DRAWN BY	
SHEET NUMBER		

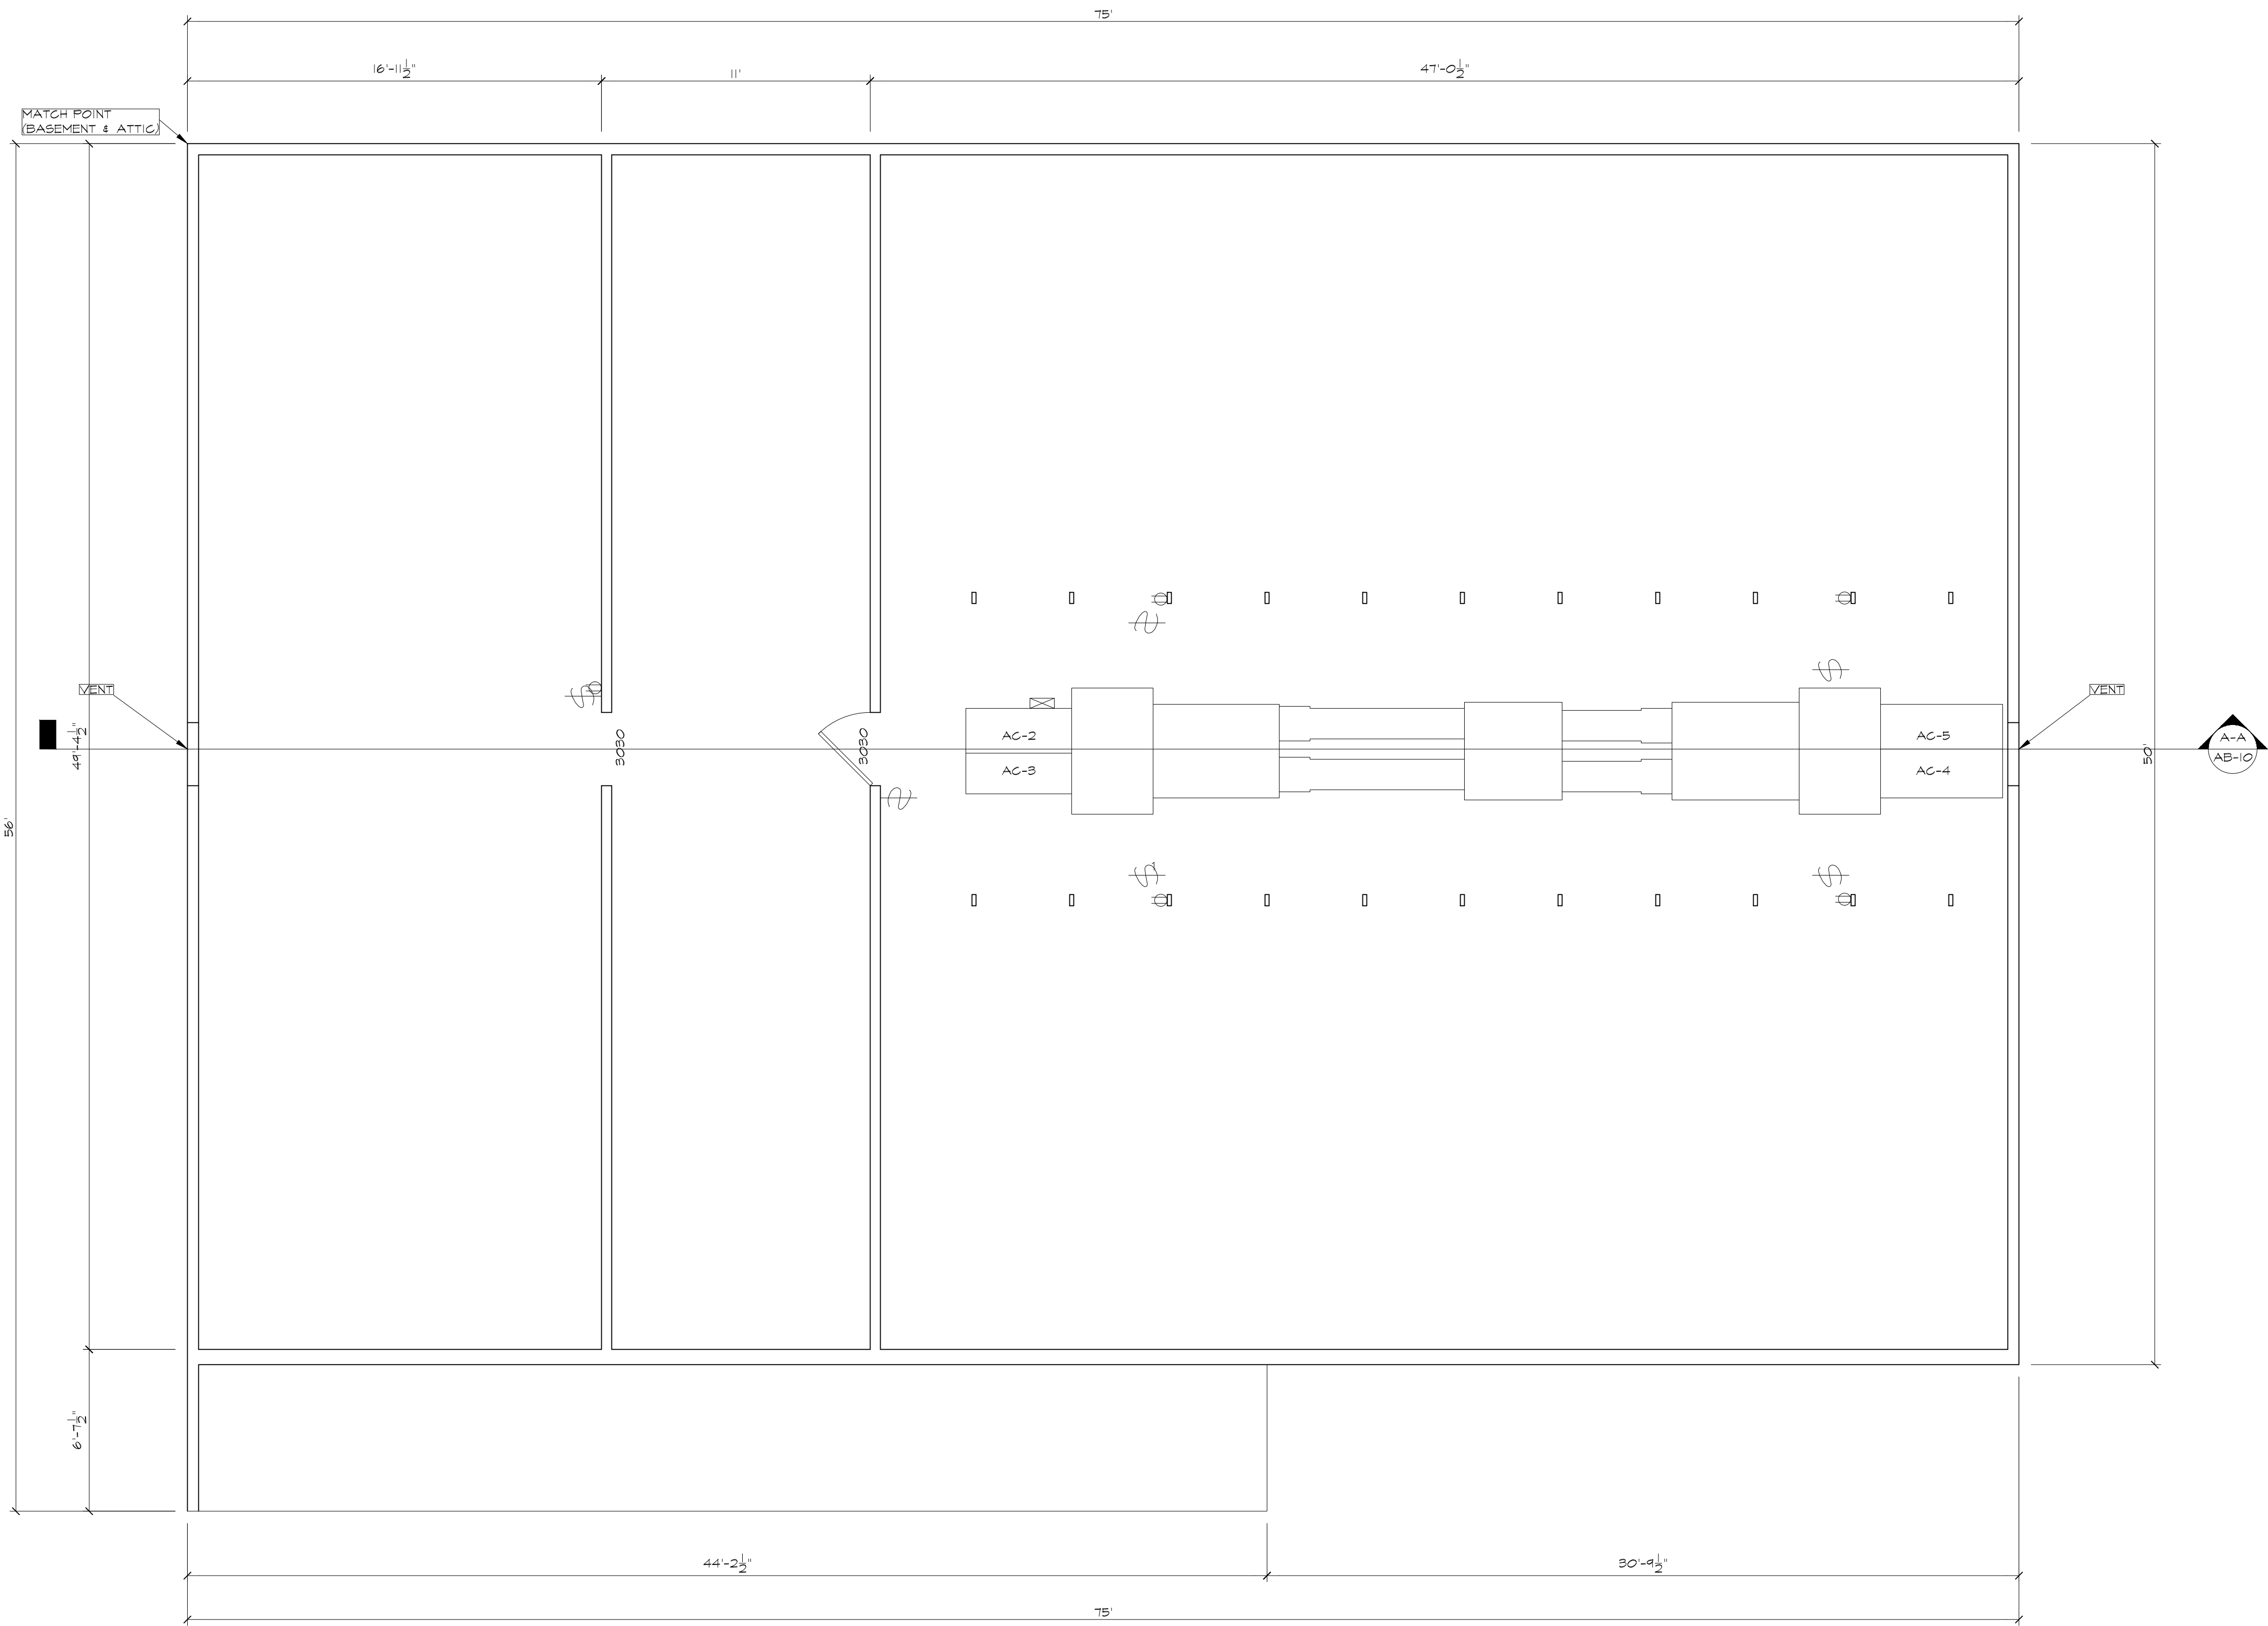

ATTIC PLAN 1/4"=1'-0"

ARCHITECTURAL AS BUILT
SANTA BARBARA, CA 93018

01 100% SUBMISSION SEE COVER SHEET

NO. ISSUES | REVISIONS DATE

SHEET TITLE

ATTIC ELECTRICAL

HL PROJECT MANAGER

HL PROJECT DIRECTOR

012317-1 PROJECT NUMBER

1/4"=1'-0" SCALE

CL DRAWN BY


SHEET NUMBER

AB-9



ARCHITECTURAL AS BUILT

SANTA BARBARA, CA 93018

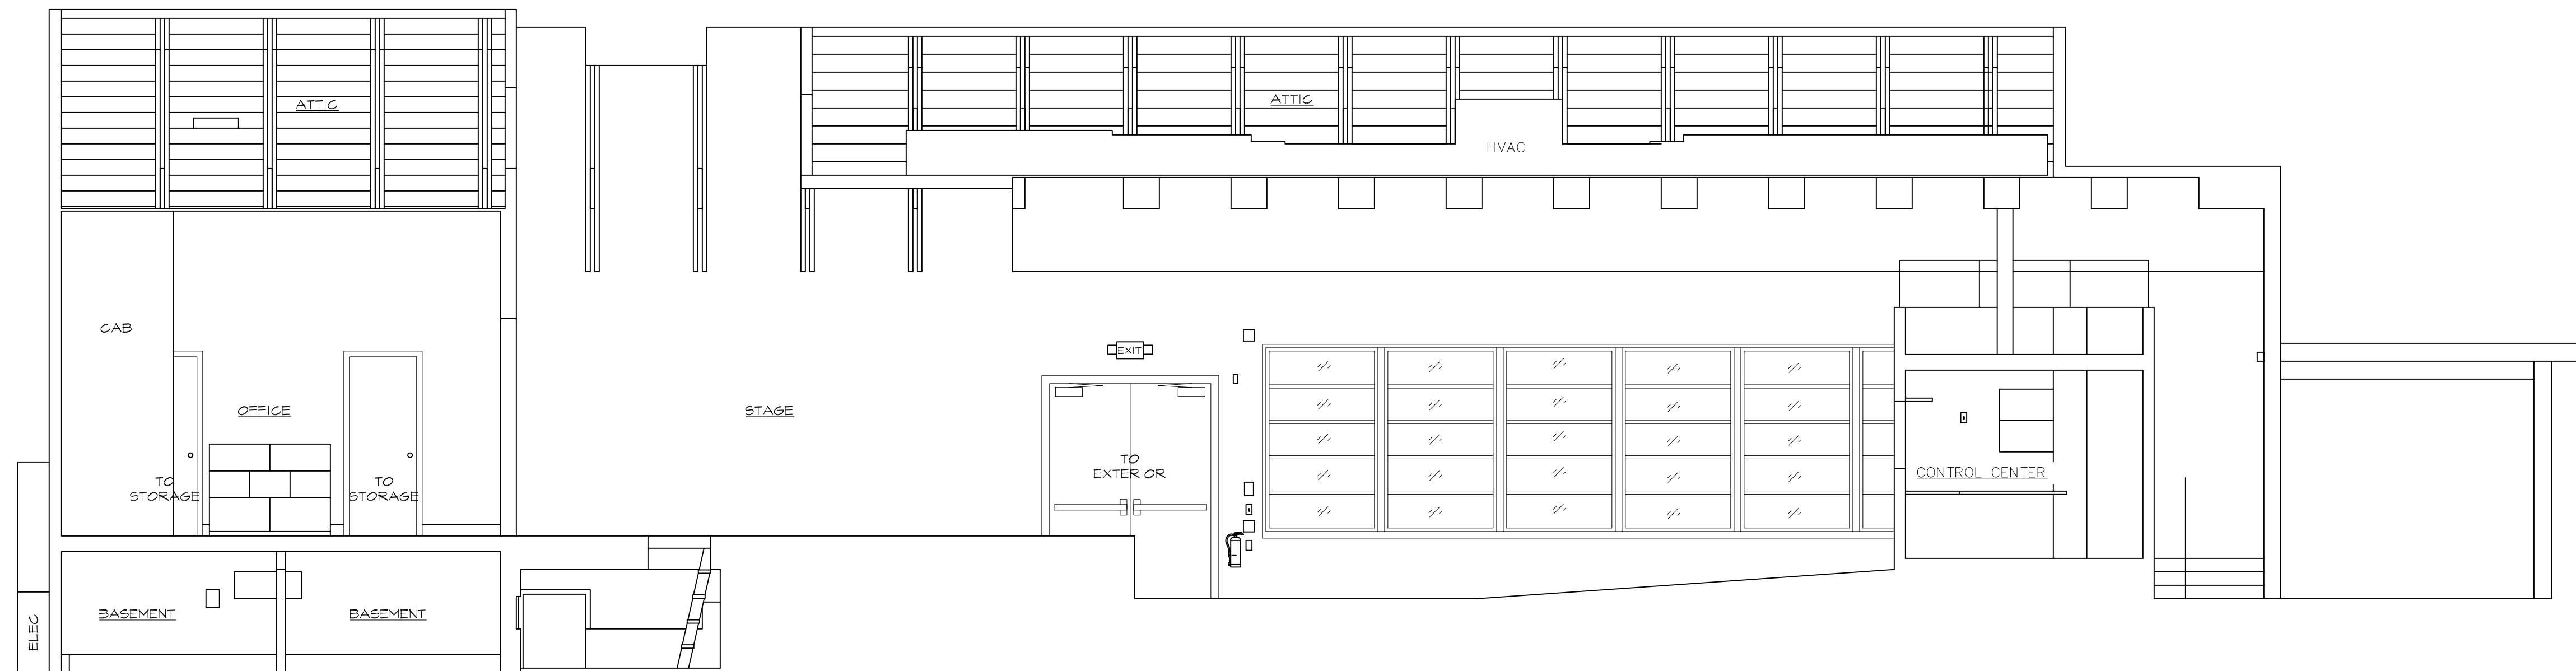

01	100% SUBMISSION	SEE COVER SHEET
NO.	ISSUES REVISIONS	DATE
		SHEET TITLE
BUILDING SECTOIN		
HL		PROJECT MANAGER
HL		PROJECT DIRECTOR
012317-1		PROJECT NUMBER
1/4"=1'-0"		SCALE
CL		DRAWN BY
		SHEET NUMBER

AB-10