


Arlington Crowne Plaza

Arlington, TX 76001



100% SUBMITTAL

C-1	COVER SHEET DRAWING INDEX
SL	SYMBOLS LEGEND
AB-1	FIRST FLOOR PLAN
AB-2	AREA "A"
AB-3	AREA "B"
AB-4	AREA "C"
AB-5	AREA "D"

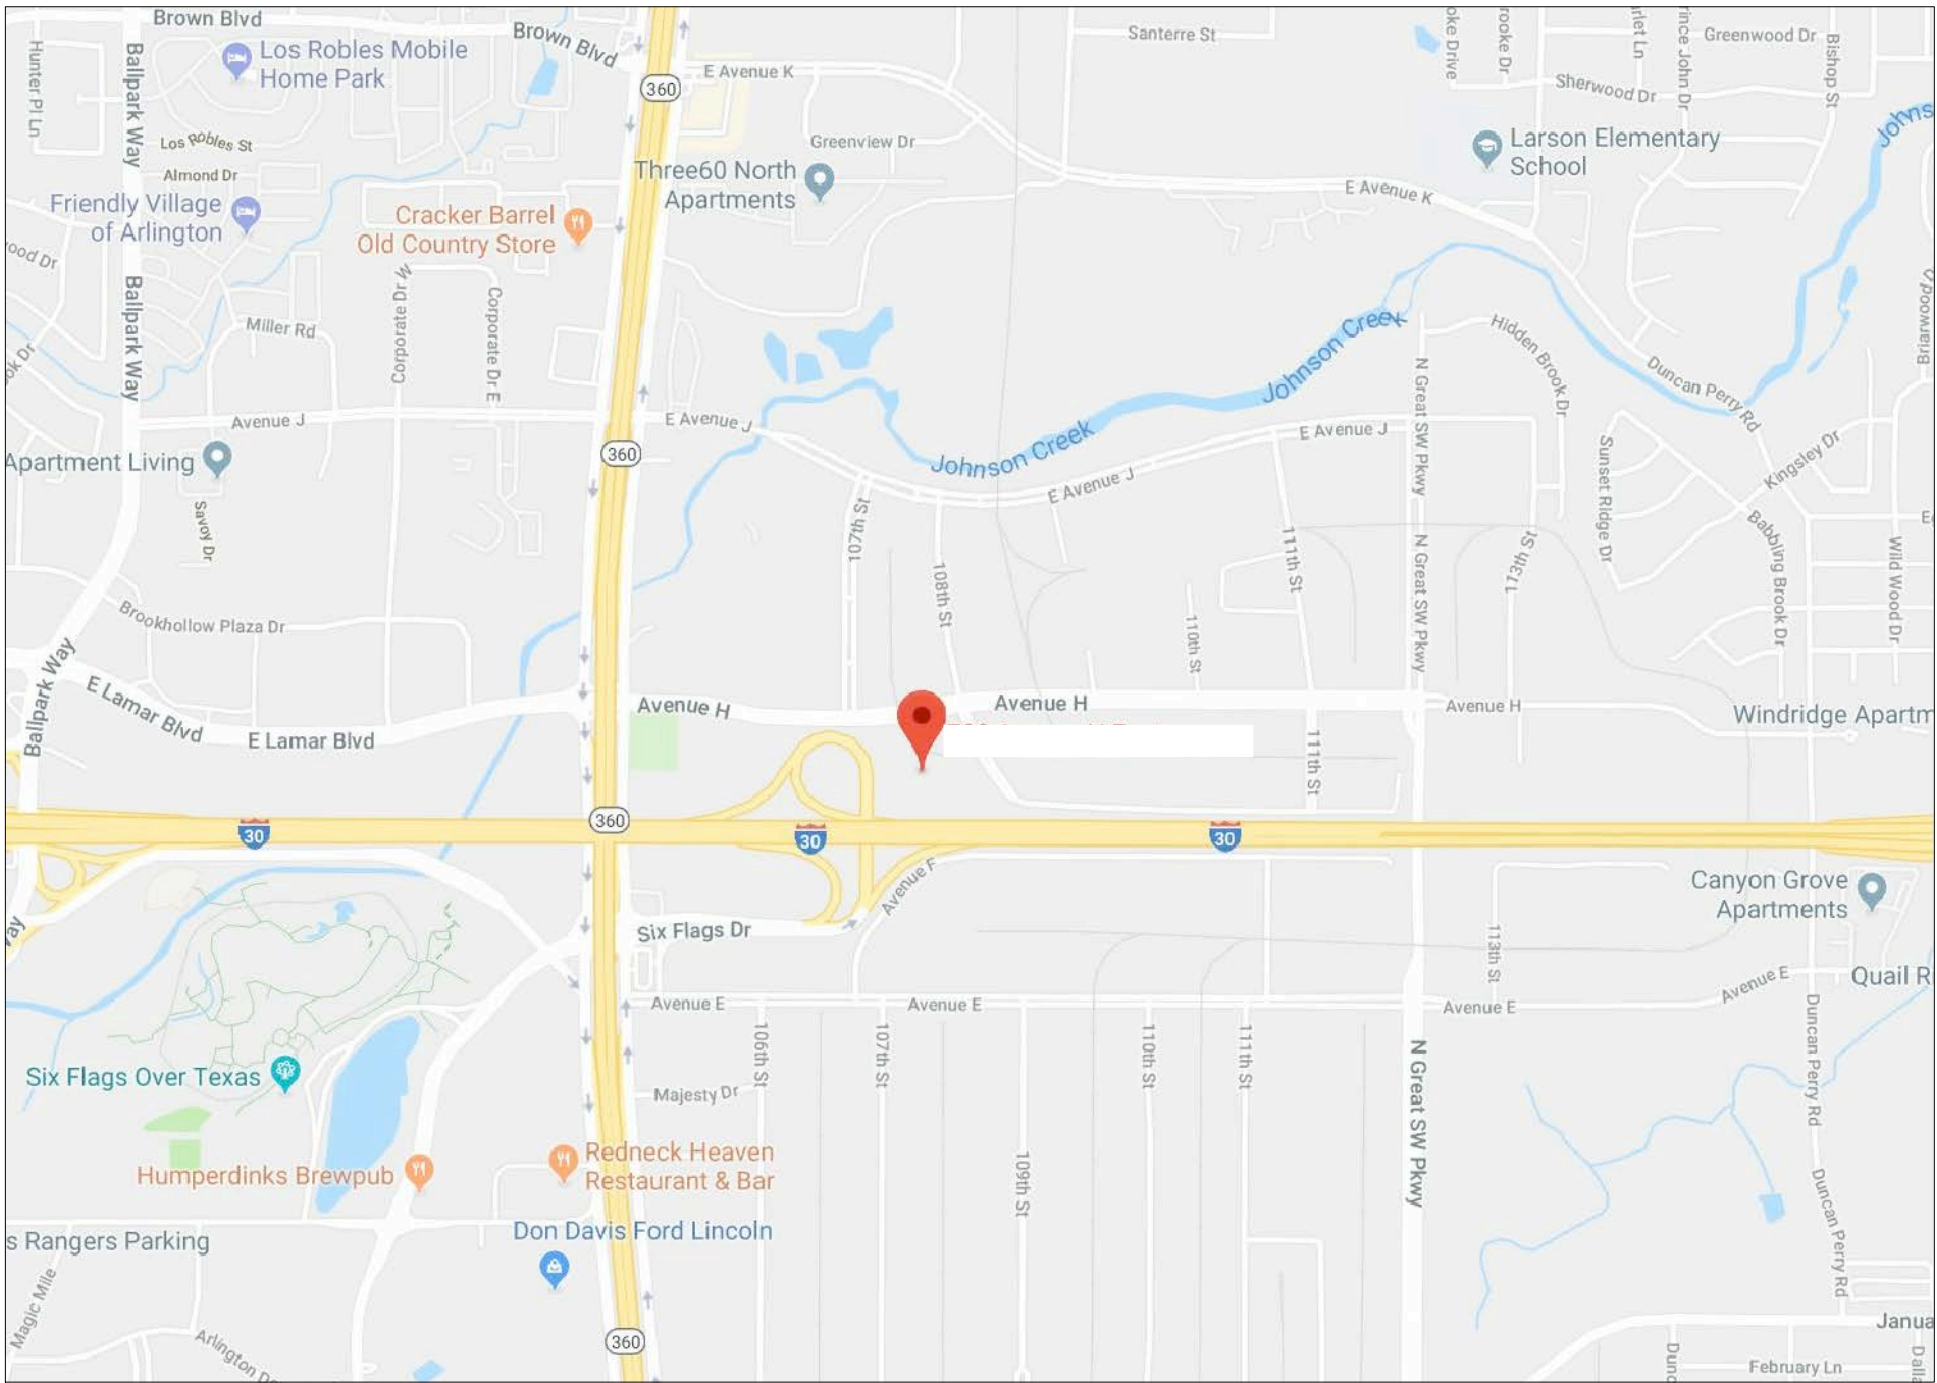

 VICINITY MAP
NTS

AREA DATA

FIRST FLOOR AREA DOCUMENTED 43,338 S.F. ±



As BUILT
PROFESSIONALS
www.asbuiltprofessionals.com

A DIVISION OF:



AEC

CONSULTANTS INC

844.272.8458
844 ASBUILT

© 2018 AEC CONSULTANTS INC

ARCHITECTURAL AS BUILT
Arlington Crowne Plaza
Arlington, TX 76001

01	100% SUBMISSION	SEE COVER SHEET
NO.	ISSUES REVISIONS	DATE
		SHEET TITLE
COVER SHEET		
HL		PROJECT MANAGER
HL		PROJECT DIRECTOR
012318-1		PROJECT NUMBER
		SCALE
CL		DRAWN BY
		SHEET NUMBER

C-1

SYMBOLS LEGEND

RCP

	EXHAUST VENT		TRACK LIGHT OR VANITY LIGHT
	CEILING MOUNTED LIGHT FIXTURE		WALL-MOUNTED LIGHT FIXTURE
	CEILING MOUNTED DIRECTIONAL LIGHT		EMERGENCY EXIT SIGN
	RECESSED CAN LIGHT		EMERGENCY EXIT LIGHT
	EYEBALL OR SMALL CAN LIGHT		EMERGENCY EXIT LIGHT W/ SIGN
	PENDANT LIGHT		LIGHTED STAIR SIGN
	INDIVIDUAL FLUOR. LAY-IN FIXTURE 4 BULB		FLOOD LIGHT
	INDIVIDUAL FLUOR. HANGING FIXTURE 2 BULB		PHOTO CELL
	INDIVIDUAL FLUOR. FLUSH MOUNT FIXTURE 4 BULB		CEILING FAN
	CAMERA		CEILING FAN W/ LIGHT KIT
	MOTION DET.		7-2-6 CEILING HEIGHT AND TRIM 7'-2" ABOVE FLOOR BELOW WITH 6" CROWN MOULDING. NOTE: ALL CEILINGS NOT LABELED ARE PLASTER. CEILINGS SHOWN WITH A GRID ARE LAY IN ACOUSTICAL TILE..
	SUPPLY VENT		JUNCTION BOX
	SUPPLY VENT		
	RETURN VENT		
	RETURN VENT		
	SPEAKER		

ELECTRIC

	DATA OUTLET
	TELEPHONE JACK
	ELECTRIC SWITCH
	CABLE TELEVISION OUTLET
	DUPLEX RECEPTACLE OUTLET
	SPECIAL PURPOSE CONNECTION OR OUTLET
	QUADRUPLX RECEPTACLE OUTLET
	FLOOR DUPLEX RECEPTACLE OUTLET
	ELECTRIC PANEL
	ELECTRIC METER
	BUTTON SWITCH
	DISCONNECT SWITCH
	GROUND/FLOOR LIGHT
	KEY PAD

FIRE PROTECTION

	FIRE EXTINGUISHER
	FIRE PULL
	FIRE ALARM (HORN/SRTOBE)
	SMOKE DETECTOR
	SMOKE ALARM SPEAKER
	SPRINKLER HEAD CEILING MOUNT
	SPRINKLER HEAD WALL MOUNT

MEP

	THERMOSTAT
	FLOOR DRAIN
	VALVE
	HOSE BIB
	WATER SUPPLY
	SUSPENDED GAS HEATER

MISC

	BOLLARD
	11-4-11/16 SPOT ELEVATION

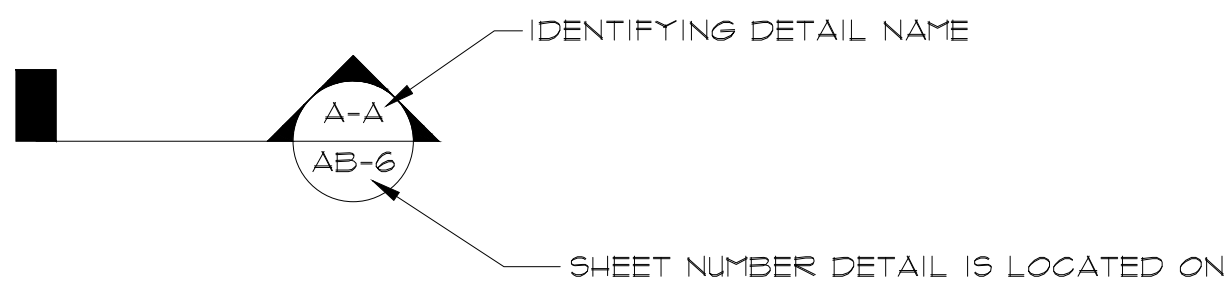
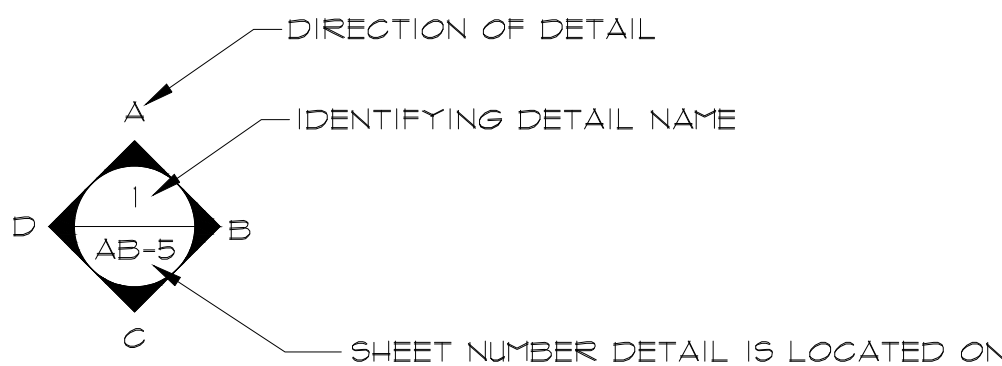


PHOTO DOCUMENTATION LEGEND

INDICATES LOCATION OF CAMERA

INDICATES DIRECTION OF CAMERA LENS AND CORRESPONDING PHOTO / VIDEO NUMBER

TYPES OF DOCUMENTATION

GROUND BASED PHOTO

GROUND BASED VIDEO

360° SHPERICAL PHOTO

AERIAL BASED PHOTO

AERIAL BASED VIDEO

ARCHITECTURAL AS BUILT
Arlington Crowne Plaza
Arlington, TX 76001

01	100% SUBMISSION	SEE COVER SHEET
NO.	ISSUES REVISIONS	DATE

SHEET TITLE

HL PROJECT MANAGER

HL PROJECT DIRECTOR

012318-1 PROJECT NUMBER

NO SCALE SCALE

CL DRAWN BY

SHEET NUMBER

SL



ARCHITECTURAL AS BUILT

Arlington Crowne Plaza

Arlington, TX 76001




01	100% SUBMISSION	SEE COVER SHEET
NO.	ISSUES REVISIONS	DATE
		SHEET TITLE
H/L	PROJECT MANAGER	
H/L	PROJECT DIRECTOR	
012318-1	PROJECT NUMBER	
3/32"=1'-0"		SCALE
CL	DRAWN BY	
	SHEET NUMBER	

AB-1



AB-2

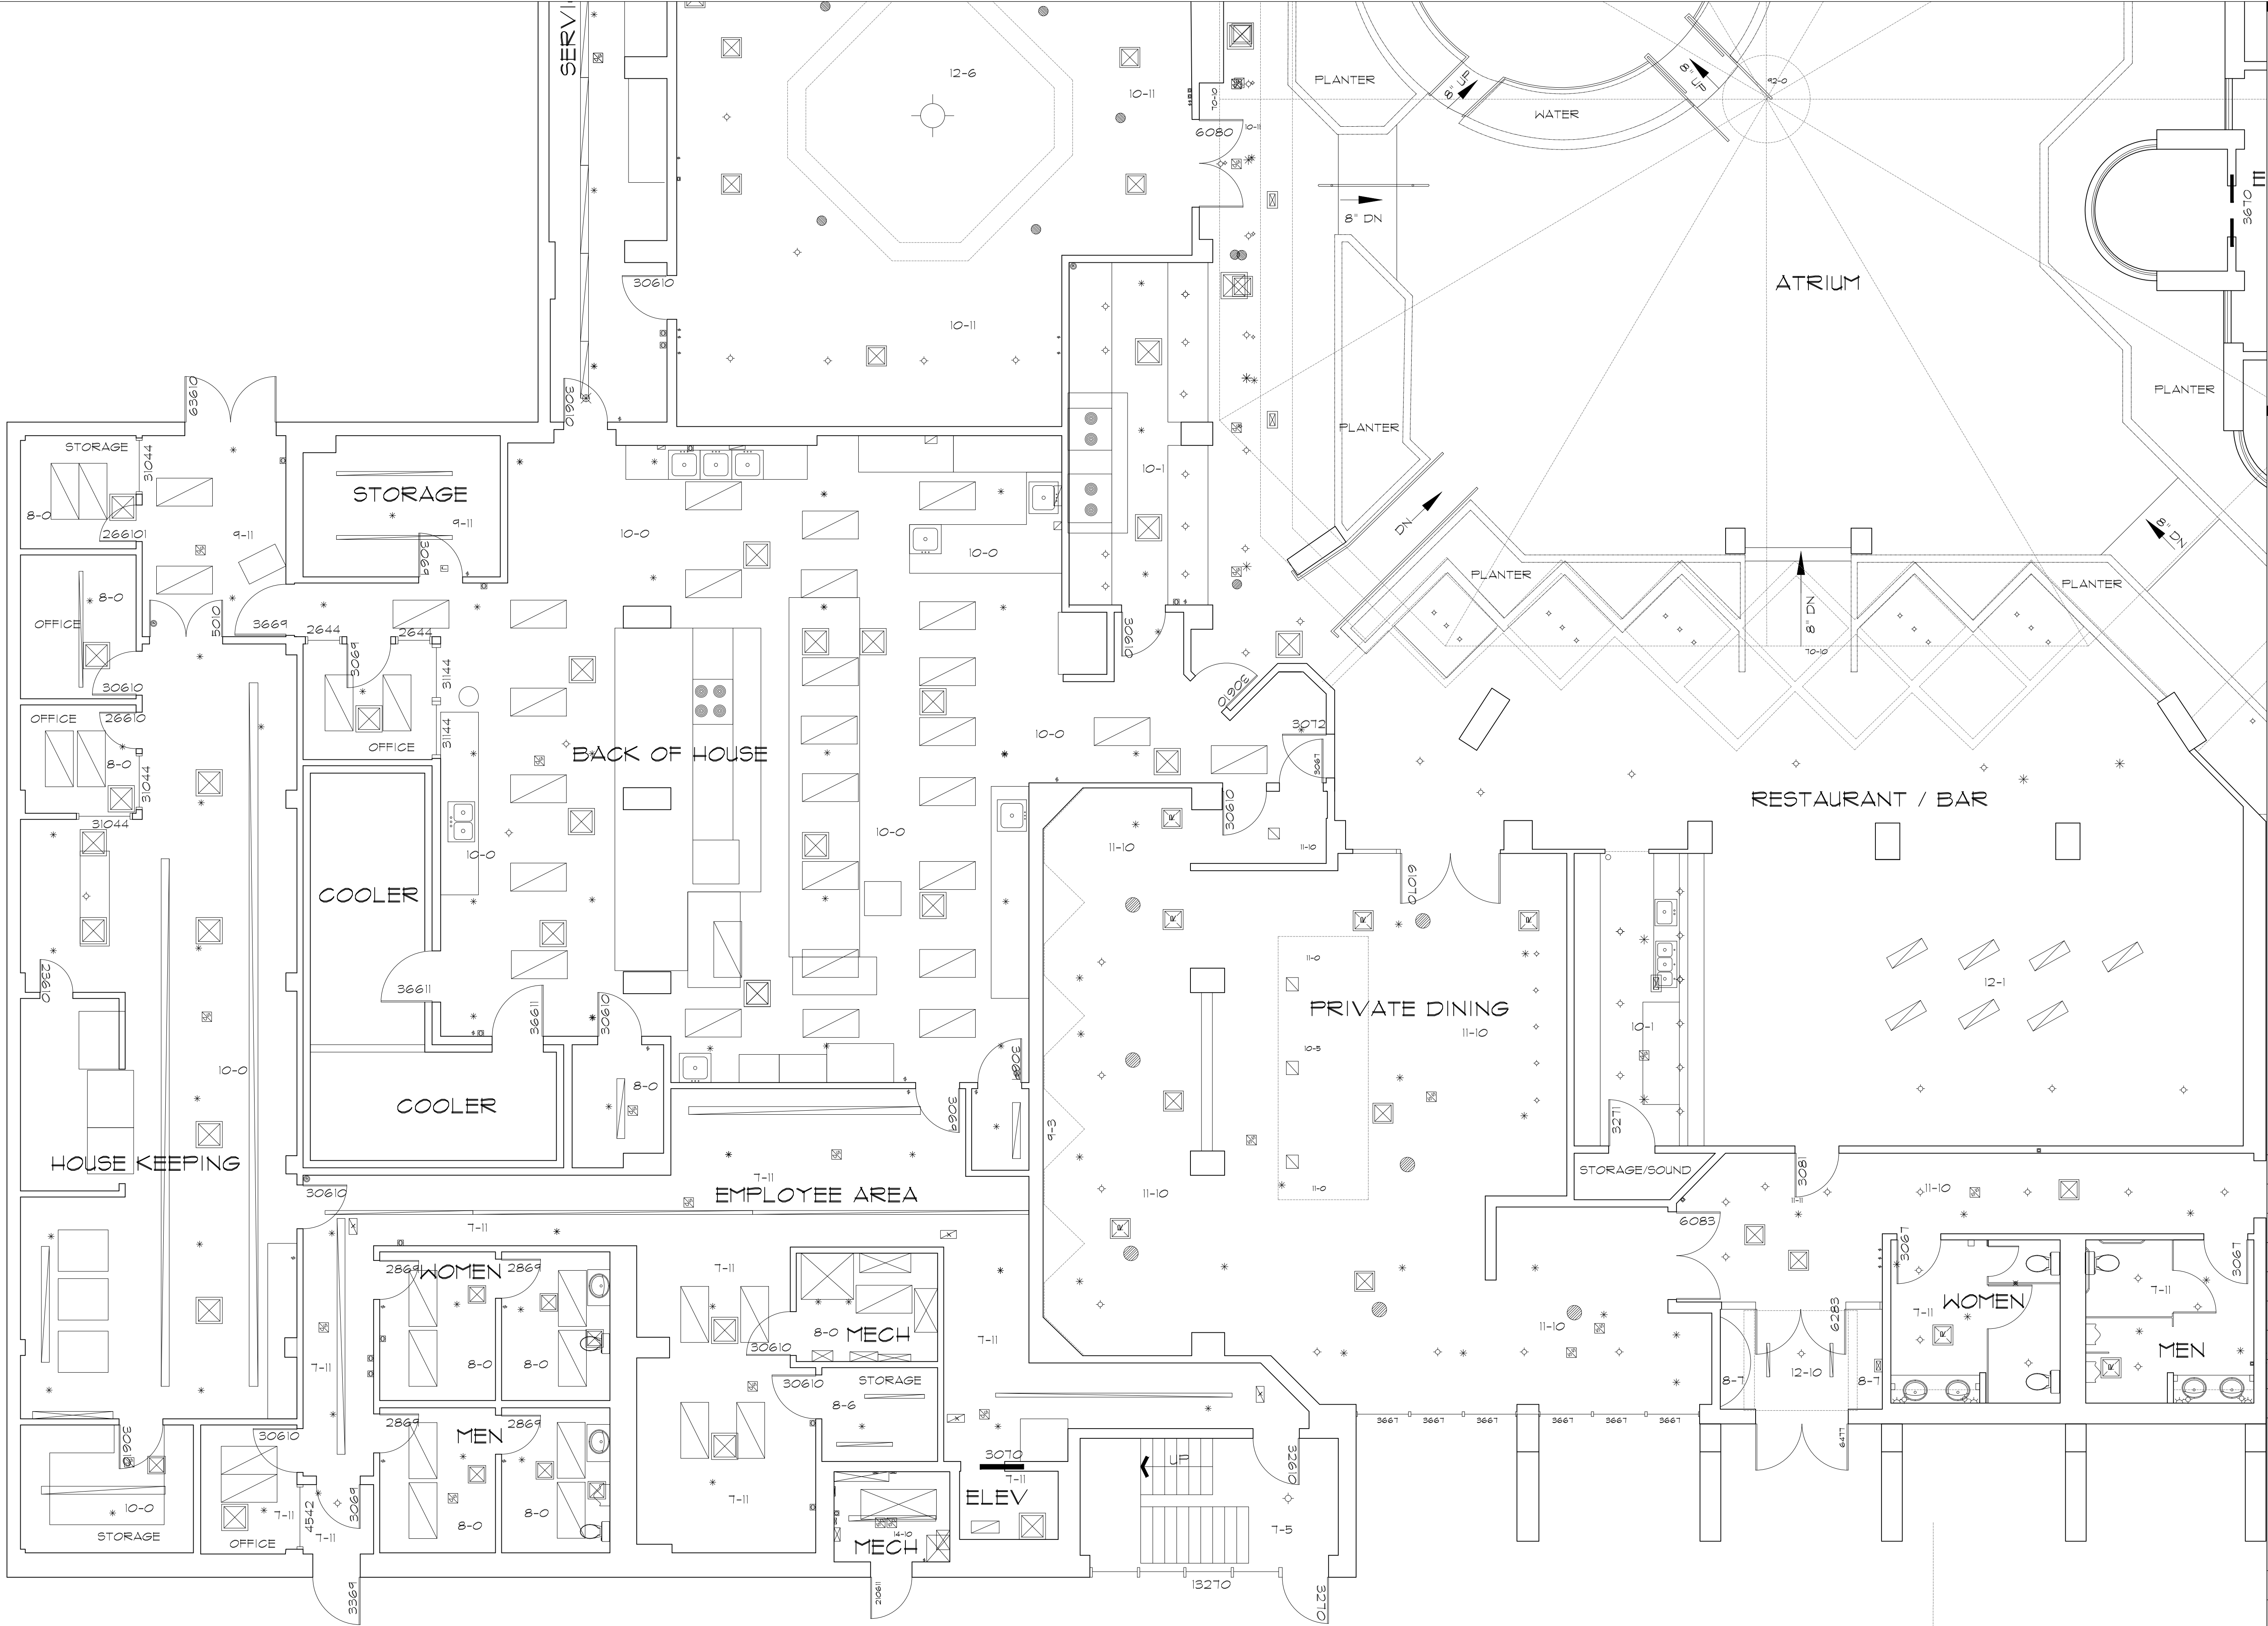


ARCHITECTURAL AS BUILT
Arlington Crowne Plaza

Arlington, TX 76001

01	100% SUBMISSION	SEE COVER SHEET
NO.	ISSUES REVISIONS	DATE
		SHEET TITLE
HL	PROJECT MANAGER	
HL	PROJECT DIRECTOR	
012318-1	PROJECT NUMBER	
3/16"=1'-0"	SCALE	
CL	DRAWN BY	
	SHEET NUMBER	

AB-3

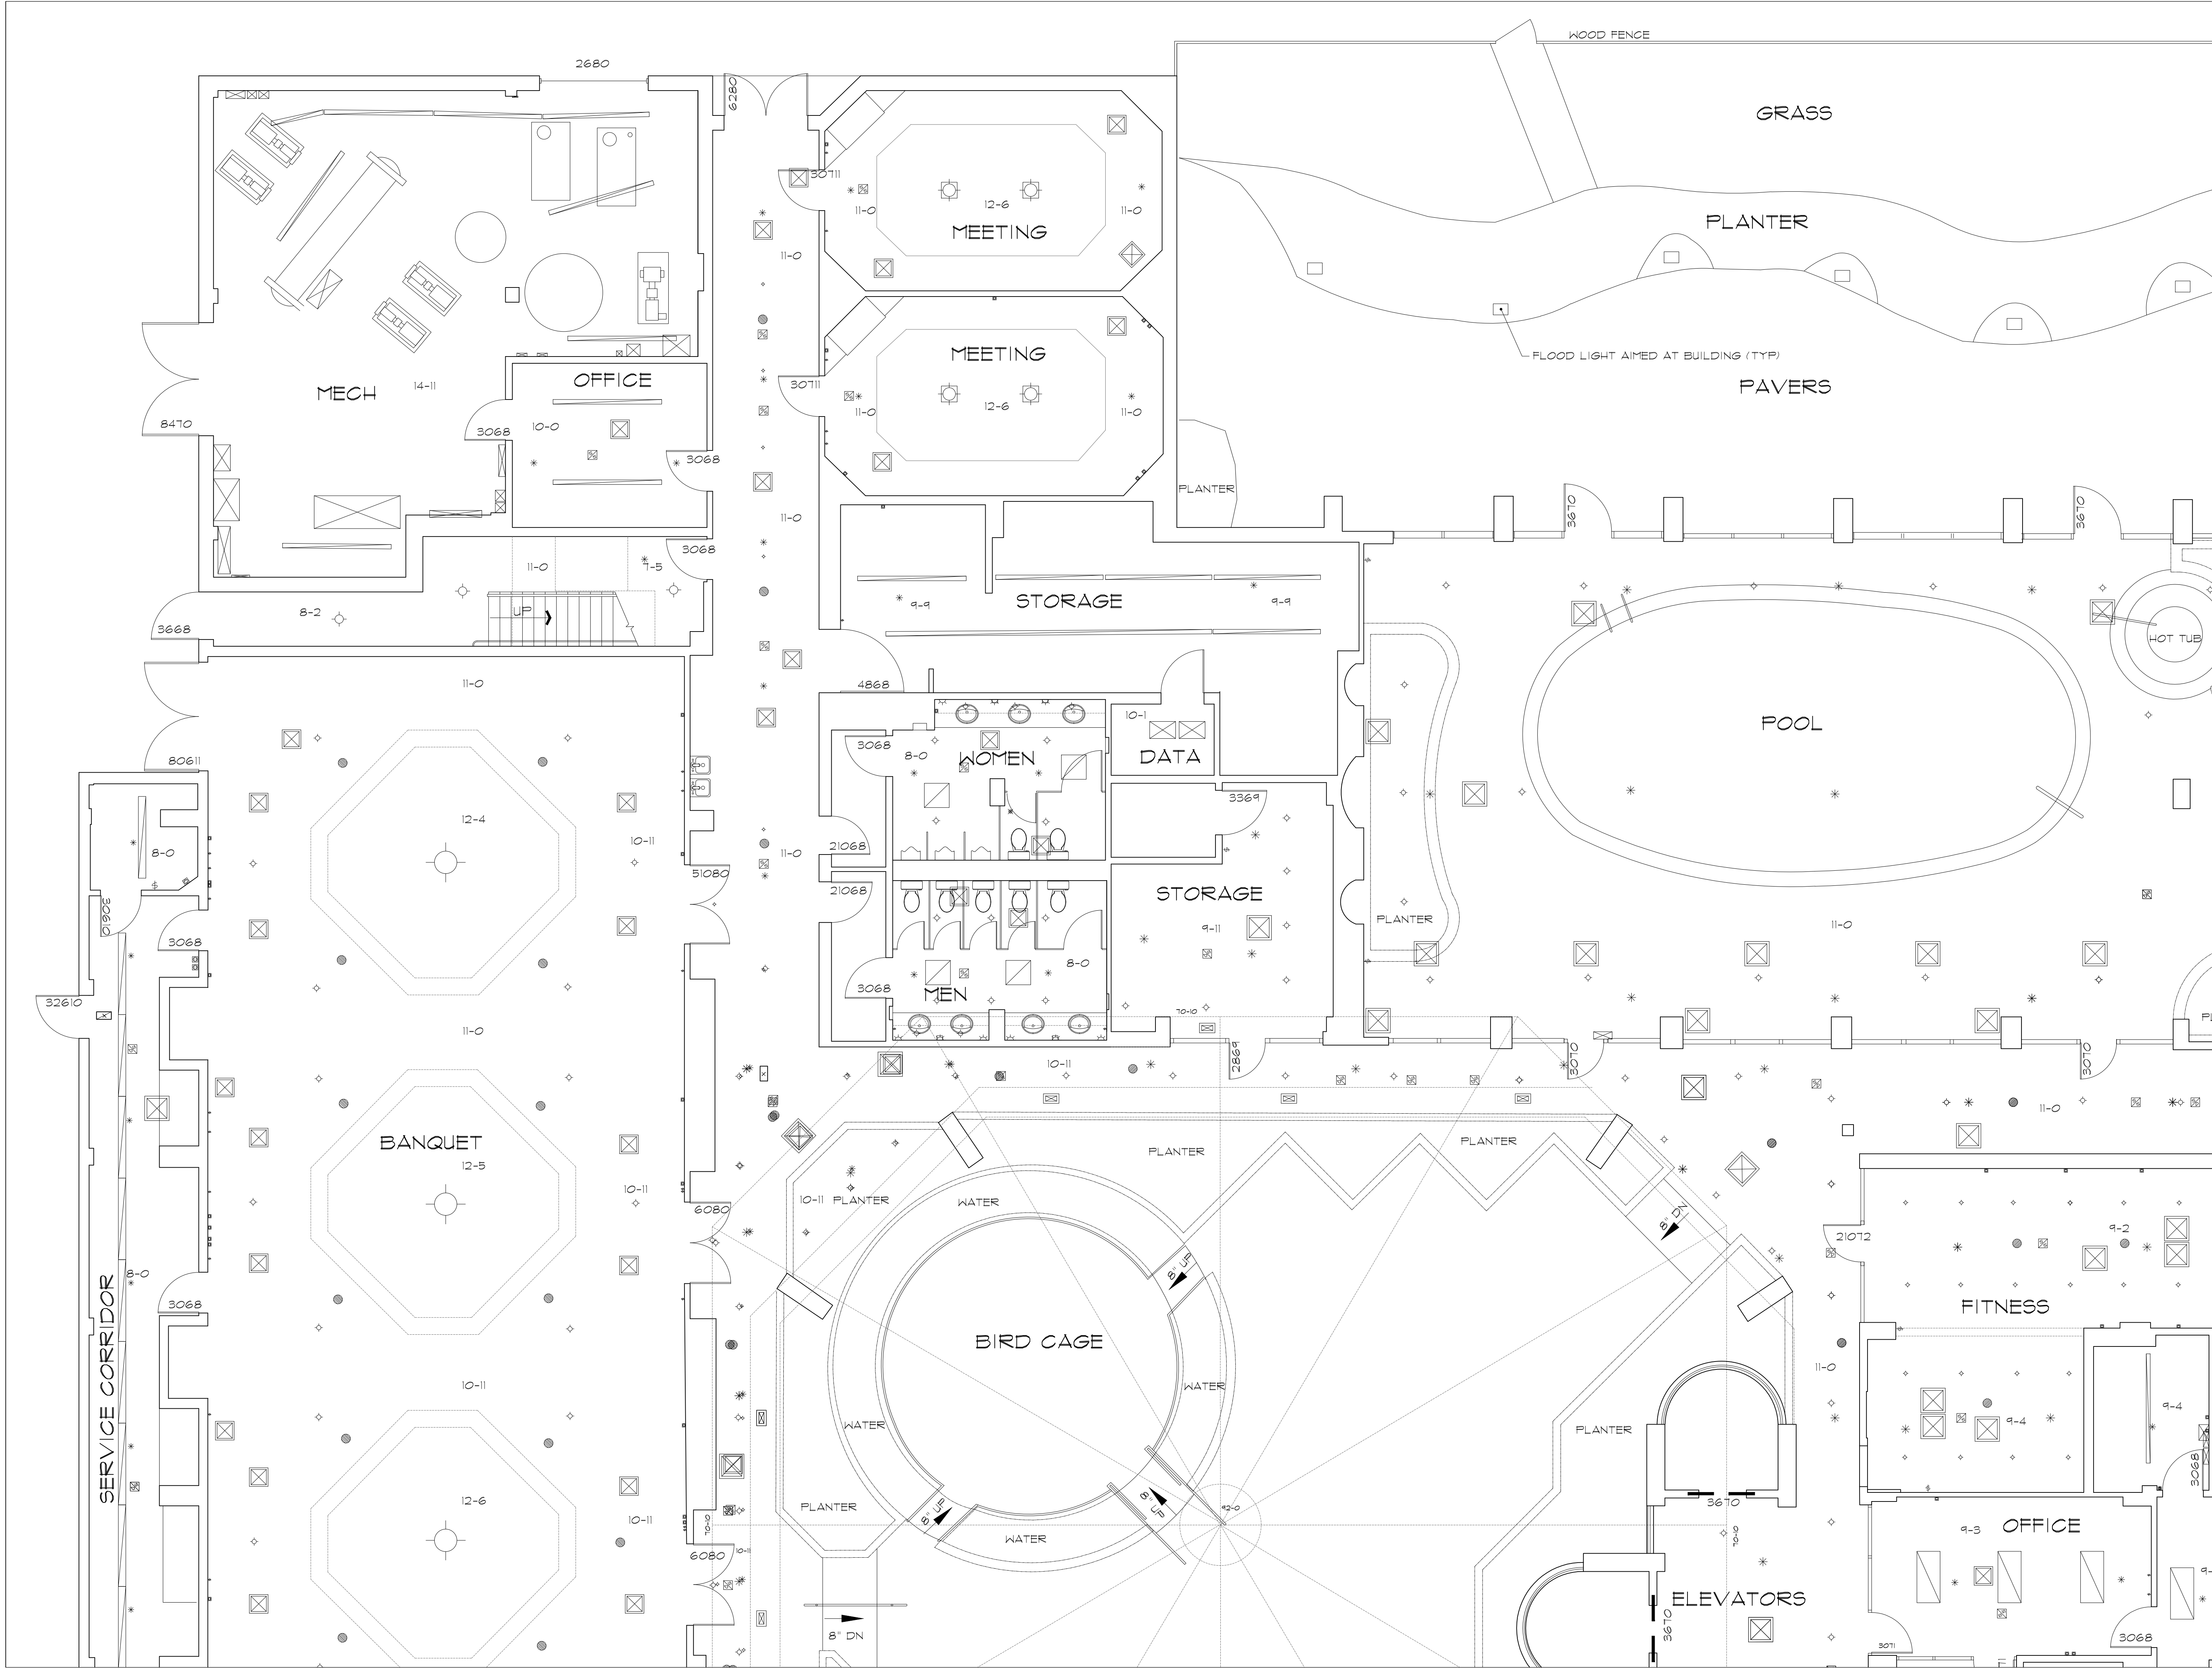


ARCHITECTURAL AS BUILT
Arlington Crowne Plaza

Arlington, TX 76001

01	100% SUBMISSION	SEE COVER SHEET
NO.	ISSUES REVISIONS	DATE
		SHEET TITLE
HL	PROJECT MANAGER	
HL	PROJECT DIRECTOR	
012318-1		PROJECT NUMBER
3/16"=1'-0"		SCALE
CL	DRAWN BY	
		SHEET NUMBER

AB-4

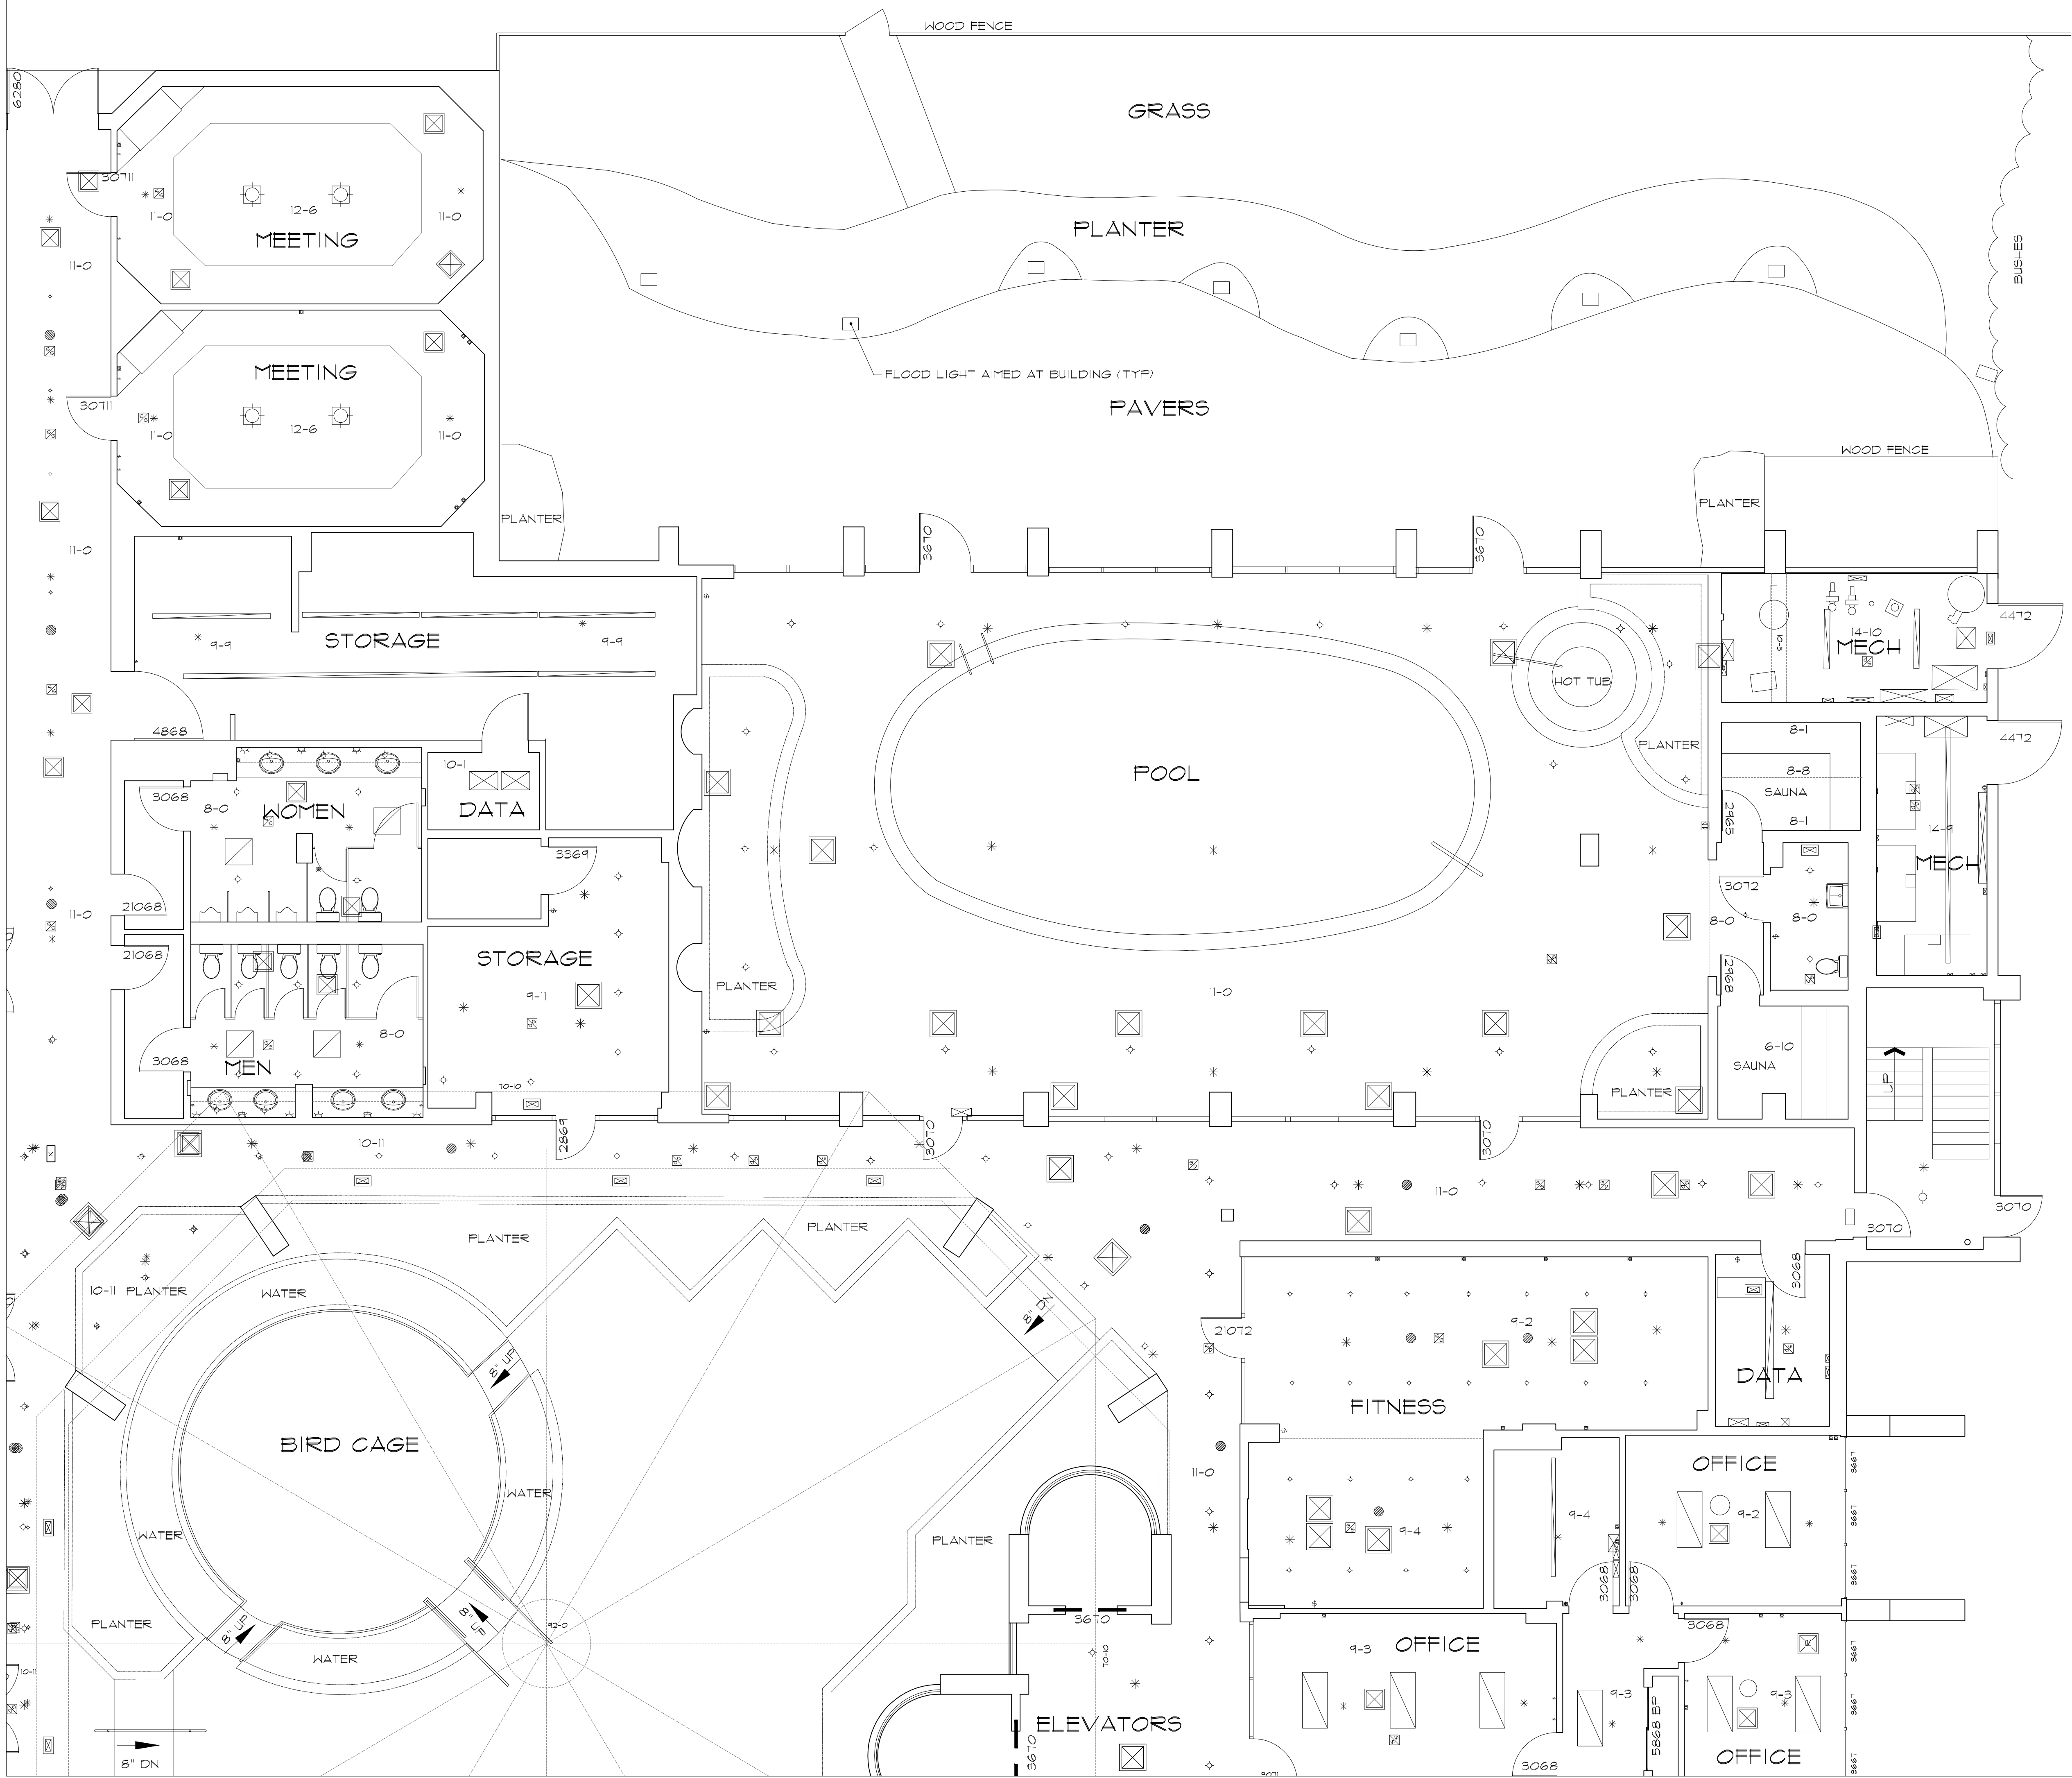

As BUILT

PROFESSIONALS

www.asbuiltprofessionals.com

A DIVISION OF:

AEC

CONSULTANTS INC

844.272.8458

844 ASBUILT

© 2018 AEC CONSULTANTS INC

ARCHITECTURAL AS BUILT

Arlington Crowne Plaza

Arlington, TX 76001

01	100% SUBMISSION	SEE COVER SHEET
NO.	ISSUES REVISIONS	DATE
		SHEET TITLE
HL	PROJECT MANAGER	
HL	PROJECT DIRECTOR	
012318-1	PROJECT NUMBER	
3/16"=1'-0"	SCALE	
CL	DRAWN BY	
		SHEET NUMBER

AB-5