

SYMBOLS LEGEND

RCP

ELECTRIC

EXHAUST VENT

CEILING MOUNTED LIGHT FIXTURE

RECESSED CAN LIGHT

INDIVIDUAL FLUOR. LAY-IN FIXTURE 4 BULB

INDIVIDUAL FLUOR. HANGING FIXTURE 2 BULB

INDIVIDUAL FLUOR. FLUSH MOUNT FIXTURE 4 BULB

CAMERA

MOTION DET.

SUPPLY VENT

SUPPLY VENT

RETURN VENT

RETURN VENT

TRACK LIGHTING LIGHT FIXTURE

WALL-MOUNTED LIGHT FIXTURE

EMERGENCY EXIT SIGN

EMERGENCY EXIT LIGHT

EMERGENCY EXIT LIGHT W/ SIGN

FLOOD LIGHT

PHOTO CELL

CEILING FAN

CEILING FAN W/ LIGHT KIT

SPEAKER

DATA OUTLET

TELEPHONE JACK

ELECTRIC SWITCH

CABLE TELEVISION OUTLET

DUPLEX RECEPTACLE OUTLET

SPECIAL PURPOSE CONNECTION OR OUTLET

QUADRUPLUX RECEPTACLE OUTLET

FLOOR DUPLEX RECEPTACLE OUTLET

ELECTRIC PANEL

ELECTRIC METER

BUTTON SWITCH

DISCONNECT SWITCH

GROUND/FLOOR LIGHT

FIRE PROTECTION

FIRE EXTINGUISHER

FIRE PULL

FIRE ALARM (HORN/SKIRT/STROBE)

SMOKE DETECTOR

SPRINKLER HEAD

MEP

THERMOSTAT

FLOOR DRAIN

VALVE

HOSE BIB

ELEVATIONS

19'-0" FLOOR / GROUND ELEVATION

7'-2'-6" CEILING HEIGHT AND TRIM 7'-2" ABOVE FLOOR BELOW WITH 6" CROWN MOULDING

FIRST FLOOR PLAN 1/4" = 1'-0"

AS BUILT PROFESSIONALS

A DIVISION OF:

AEC CONSULTANTS INC

www.aecconsultantsinc.com

844.272.8458

© 2016 AEC CONSULTANTS INC.

AS BUILT DOCUMENTATION


Diller's Delicatessen

San Francisco, CA 94104

01	ISSUES REVISIONS	DATE
SHEET TITLE		
FIRST FLOOR PLAN		
XX	PROJECT MANAGER	
HL	PROJECT DIRECTOR	
XX.XX.XX	PROJECT NUMBER	
AS NOTED	SCALE	
XX	DRAWN BY	
SHEET NUMBER		

AB-1

RCP		ELECTRIC	
	EXHAUST VENT		DATA OUTLET
	CEILING MOUNTED LIGHT FIXTURE		TELEPHONE JACK
	RECESSED CAN LIGHT		ELECTRIC SWITCH
	INDIVIDUAL FLOOR, LIVING ROOM FIXTURE 4 BULB		CABLE TELEVISION OUTLET
	INDIVIDUAL FLOOR, DINING ROOM FIXTURE 2 BULB		DUPLEX RECEPTACLE
	INDIVIDUAL FLOOR, KITCHEN FIXTURE 4 BULB		SPECIAL PURPOSE CONNECTION OR OUTLET
	CAMERA		QUADPLEX RECEPTACLE OUTLET
	MOTION DET.		FLOOR OUTLET RECEPTACLE OUTLET
	SUPPLY VENT		ELECTRIC PANEL
	SUPPLY VENT		ELECTRIC METER
	RETURN VENT		BUTTON SWITCH
	RETURN VENT		DISCONNECT SWITCH
	TRACK LIGHTING LIGHT FIXTURE		GROUND/FLOOR LIGHT
	WALL MOUNTED LIGHT FIXTURE	FIRE PROTECTION	
	EMERGENCY EXIT SIGN		
	EMERGENCY EXIT LIGHT		
	EMERGENCY EXIT LIGHT W/ SIGN		
	FLOOD LIGHT		
	PHOTO CELL		FIRE EXTINGUISHER
	CEILING FAN		FIRE PULL
	CEILING FAN W/ LIGHT KIT		FIRE ALARM (HORNS/SIRENS)
	SPEAKER		SMOKE DETECTOR
			SPRINKLER HEAD
		MEP	
			THERMOSTAT
			FLOOR DRAIN
			VALVE
			HOSE BIB
		ELEVATIONS	
			FLOOR / GROUND ELEVATION
			CEILING HEIGHT AND TRIM 7'-2" ABOVE FLOOR BELOW WITH 6" CROWN MOLDING

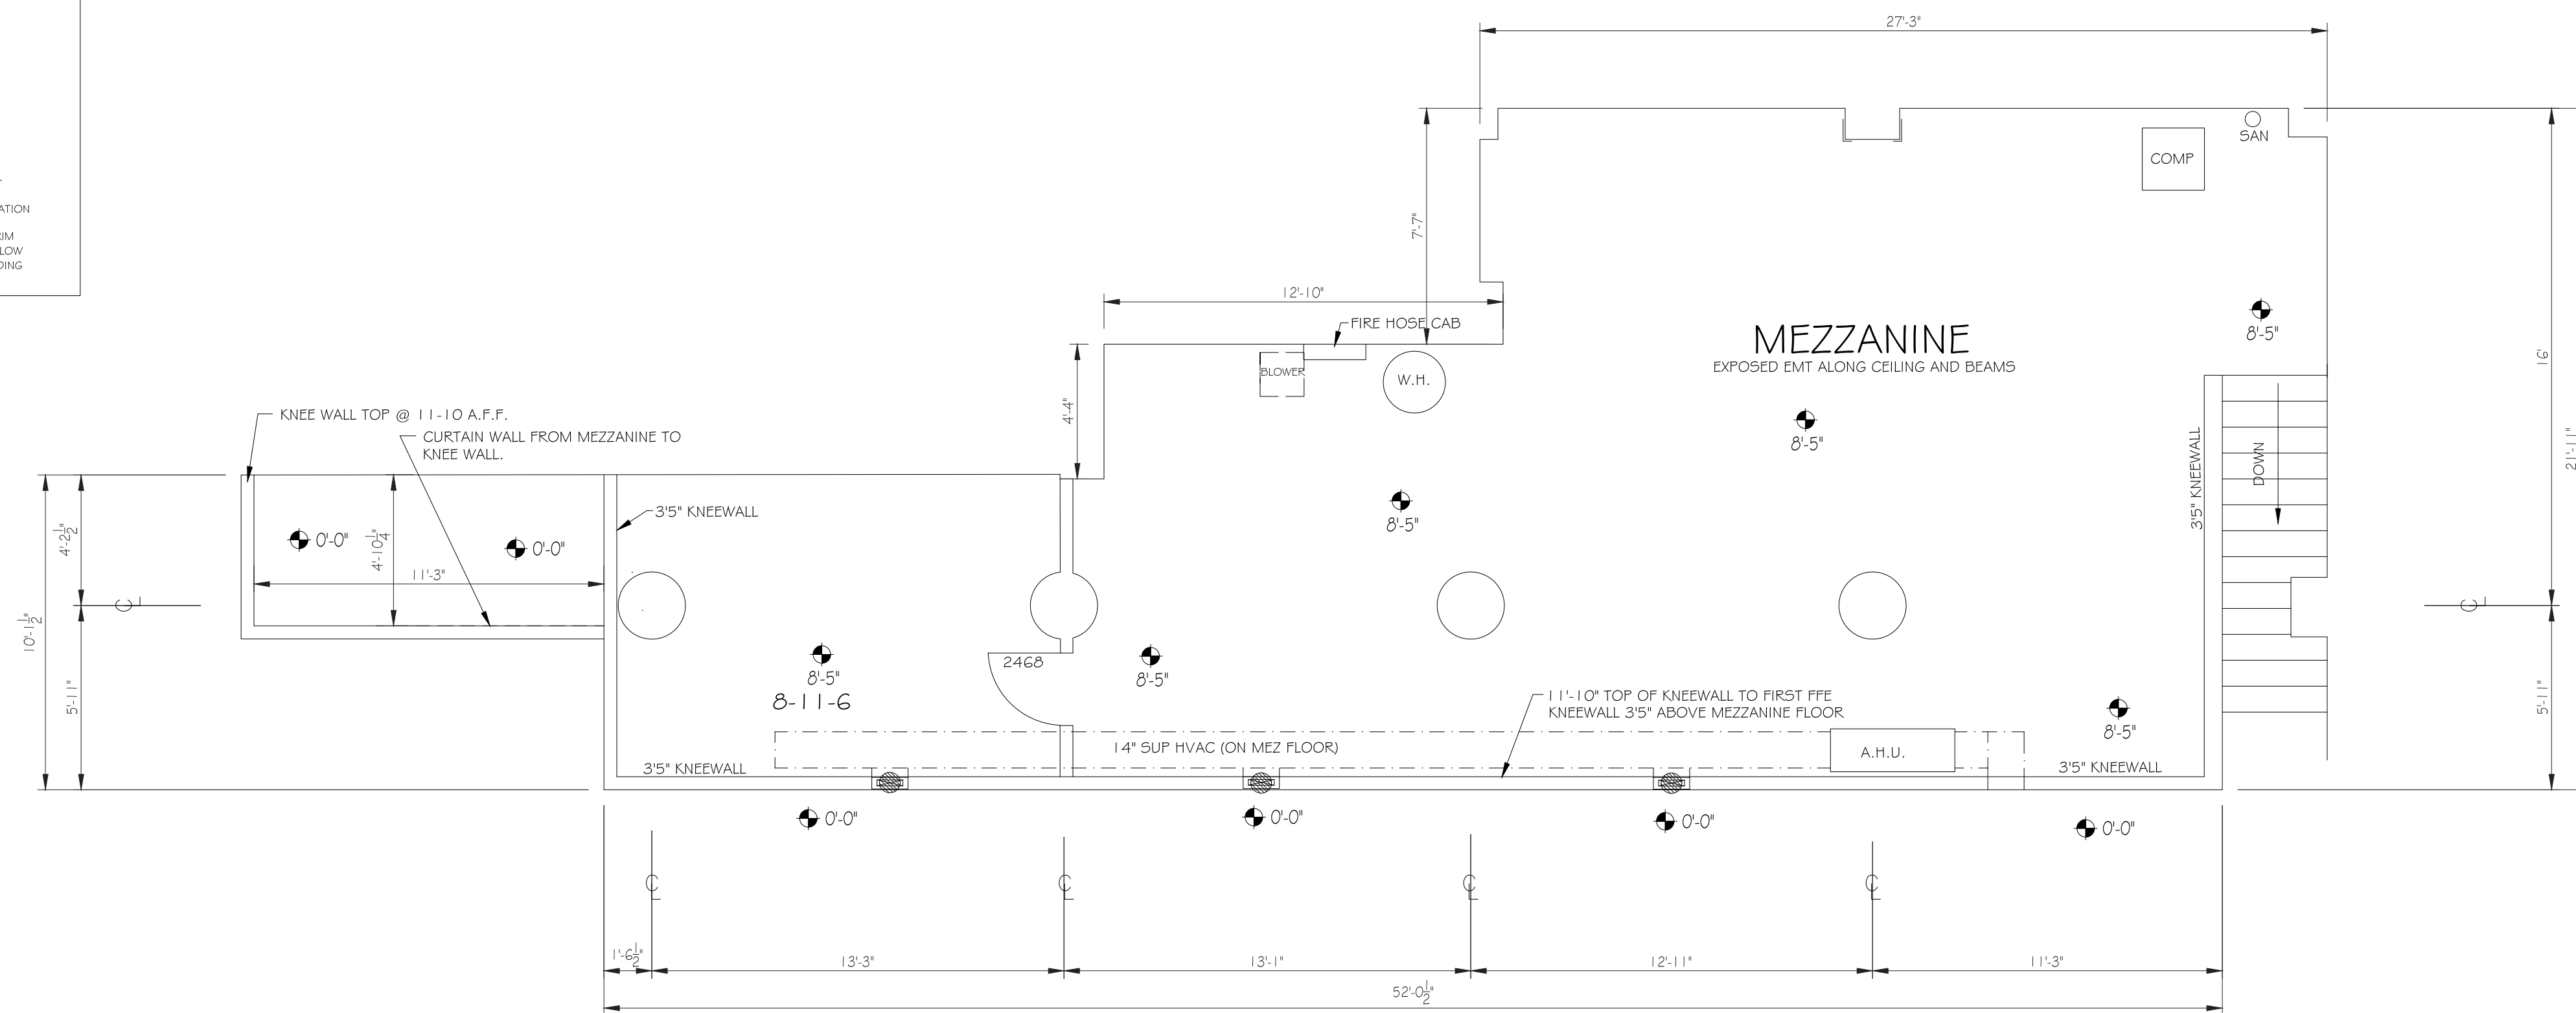

MEZZANINE PLAN $\frac{1}{4}" = 1'-0"$

AS BUILT DOCUMENTATION
Diller's Delicatessen
San Francisco, CA 94104


O1		
No.	ISSUES REVISIONS	DATE
		SHEET TITLE
SECOND FLOOR PLAN		
XX		PROJECT MANAGER
HL		PROJECT DIRECTOR
XX.XX.XX		PROJECT NUMBER
AS NOTED		SCALE
XX		DRAWN BY
		SHEET NUMBER
AB-2		

SYMBOLS LEGEND


RCP




ELECTRIC

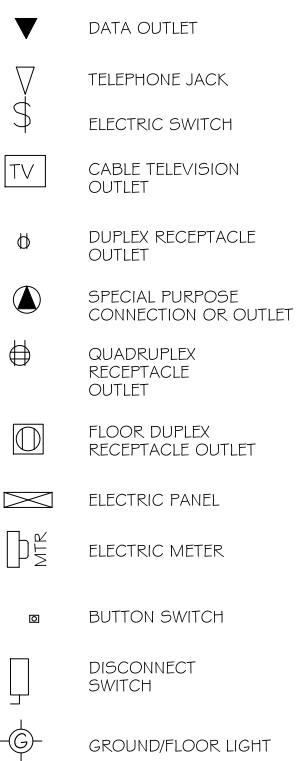


FIRE PROTECTION

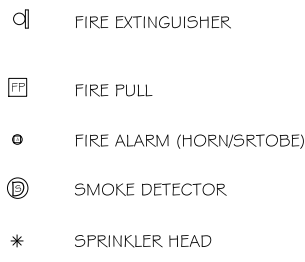

MEP

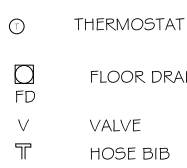

ELEVATIONS

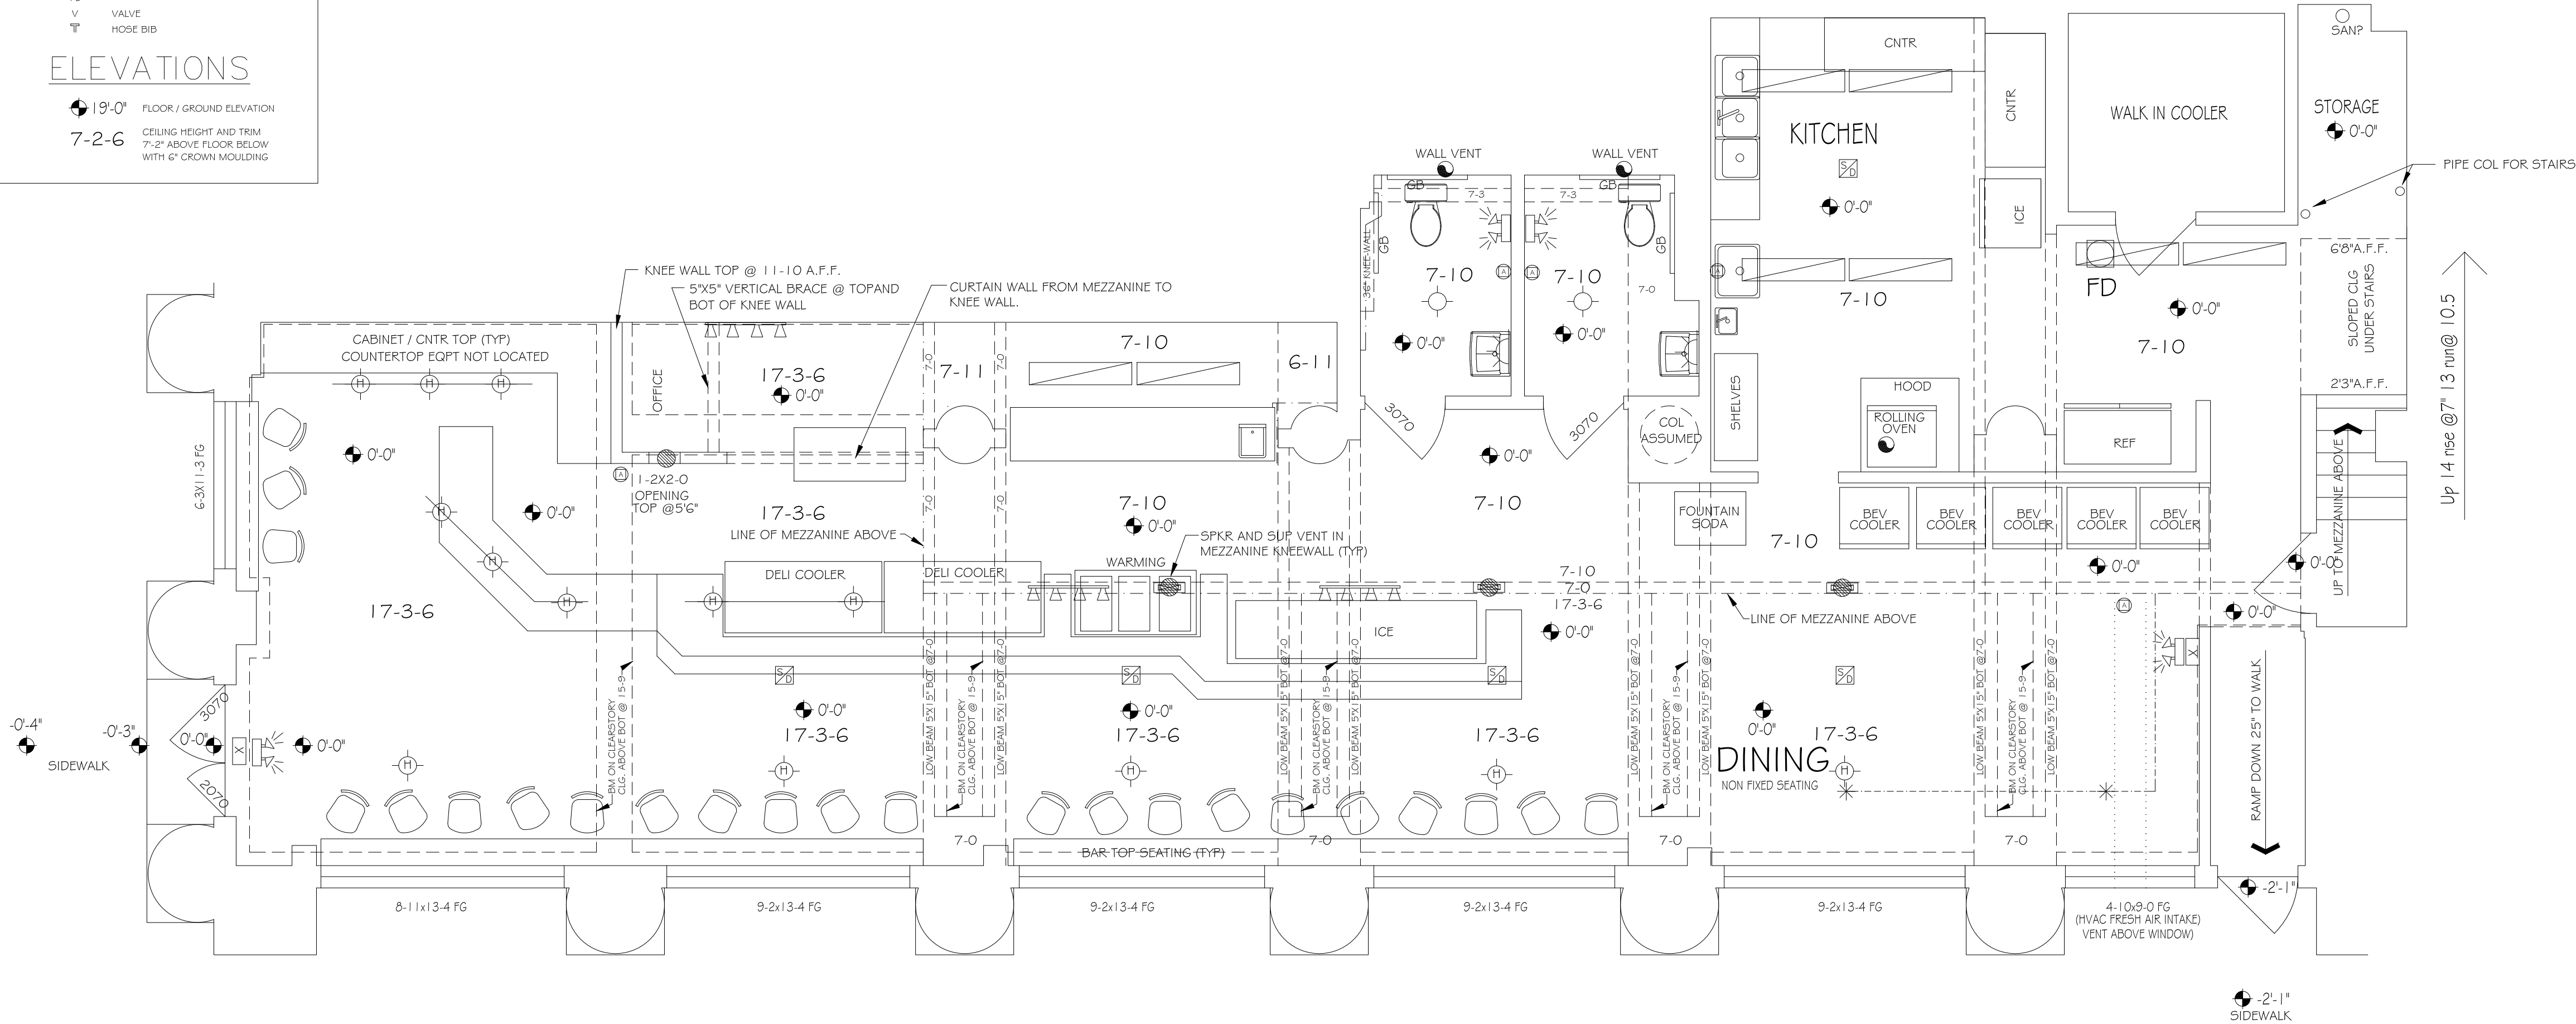

FIRST FLOOR PLAN WITH RCP 1/4"=1'-0"
ALL CEILINGS APPEAR TO BE PLASTER

AS BUILT
PROFESSIONALS
A DIVISION OF:
AEC
CONSULTANTS INC
www.aecconsultantsinc.com
844.272.8458

© 2016 AEC CONSULTANTS INC.

AS BUILT DOCUMENTATION

Diller's Delicatessen
San Francisco, CA 94104

FIRST FLOOR REFLECTED CEILING PLAN

XX	PROJECT MANAGER
HL	PROJECT DIRECTOR
XX.XX.XX	PROJECT NUMBER
AS NOTED	SCALE
XX	DRAWN BY
	SHEET NUMBER

AB-3

SYMBOLS LEGEND

RCP

EXHAUST VENT

CEILING MOUNTED LIGHT FIXTURE

RECESSED CAN LIGHT

INDIVIDUAL FLOOR LAY-IN FIXTURE 4 BULB

INDIVIDUAL FLOOR HANGING FIXTURE 2 BULB

INDIVIDUAL FLOOR FLUSH MOUNT FIXTURE 4 BULB

CAMERA

MOTION DET.

SUPPLY VENT

SUPPLY VENT

RETURN VENT

RETURN VENT

TRACK LIGHTING LIGHT FIXTURE

WALL-MOUNTED LIGHT FIXTURE

EMERGENCY EXIT SIGN

EMERGENCY EXIT LIGHT

EMERGENCY EXIT LIGHT W/ SIGN

FLOOD LIGHT

PHOTO CELL

CEILING FAN

CEILING FAN W/ LIGHT KIT

SPEAKER

ELECTRIC

DATA OUTLET

TELEPHONE JACK

ELECTRIC SWITCH

CABLE TELEVISION OUTLET

DUPLEX RECEPTACLE OUTLET

SPECIAL PURPOSE CONNECTION OR OUTLET

QUADPLEX RECEPTACLE OUTLET

FLOOR DUPLEX RECEPTACLE OUTLET

ELECTRIC PANEL

ELECTRIC METER

BUTTON SWITCH

DISCONNECT SWITCH

GROUND/FLOOR LIGHT

FIRE PROTECTION

FIRE EXTINGUISHER

FIRE PULL

FIRE ALARM (HORN/STROBE)

SMOKE DETECTOR

SPRINKLER HEAD

MEP

THERMOSTAT

FLOOR DRAIN

VALVE

HOSE BIB

ELEVATIONS

FLOOR / GROUND ELEVATION

7-2-6

CEILING HEIGHT AND TRIM
7'-2" ABOVE FLOOR BELOW
WITH 6" CROWN MOULDING

MEZZANINE PLAN WITH RCP 1/4" = 1'-0"
ALL CEILINGS APPEAR TO BE PLASTER

AS BUILT PROFESSIONALS

A DIVISION OF:

AEC

CONSULTANTS INC

www.aecconsultantsinc.com

844.272.8458

© 2016 AEC CONSULTANTS INC.

AS BUILT DOCUMENTATION

Diller's Delicatessen

San Francisco, CA 94104

01		
NO.	ISSUES REVISIONS	DATE
SHEET TITLE		
SECOND FLOOR REFLECTED CEILING PLAN		
XX		PROJECT MANAGER
HL		PROJECT DIRECTOR
XX.XX.XX		PROJECT NUMBER
AS NOTED		SCALE
XX		DRAWN BY
SHEET NUMBER		
AB-4		