

AS-BUILT DOCUMENTATION

DRAWING INDEX

- C-1 COVER SHEET | DRAWING INDEX
- SL SYMBOLS LEGEND
- AB-1 FIRST FLOOR PLAN
- AB-2 REFLECTED CEILING PLAN
- AB-3 ROOF PLAN


AS BUILT PROFESSIONALS
www.asbuiltprofessionals.com
A DIVISION OF:

AEC CONSULTANTS INC

844.272.8458
844 AS BUILT

© 2019 AEC CONSULTANTS INC

Hixson, TN 37343

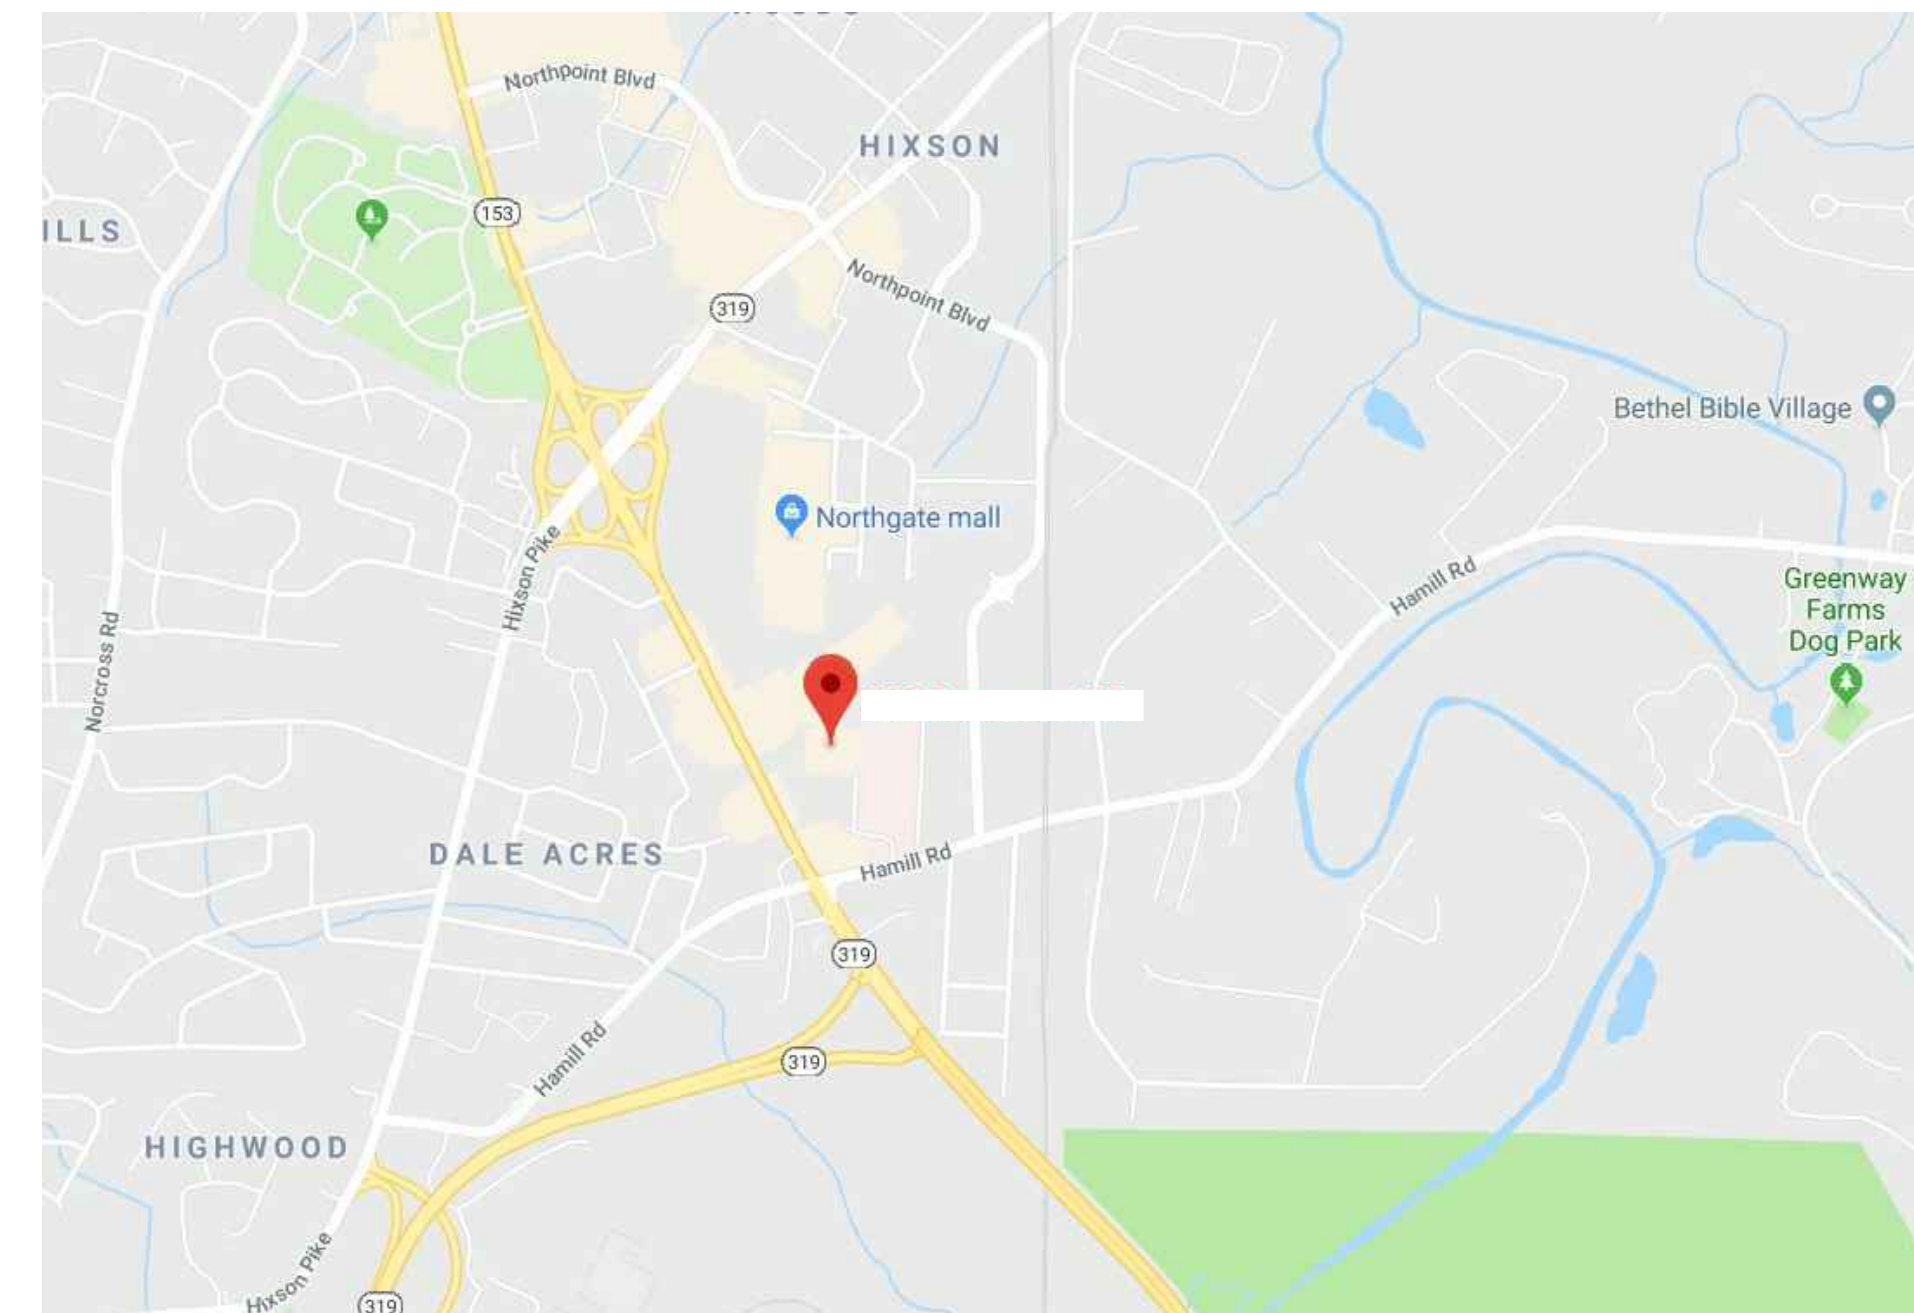

VICINITY MAP
NTS

AREA DATA	
BARGAIN HUNT	32,539 S.F. ±
BOOKS-A-MILLION	29,136 S.F. ±
SCENIC CITY	10,452 S.F. ±
BUFFET KING	10,091 S.F. ±
GRAND TOTAL	82,218 S.F. ±
ACCESSORY BUILDING	1,510 S.F. ±



100% SUBMITTAL

ARCHITECTURAL AS BUILT

Hixson, TN 37343

01	100% SUBMISSION	SEE COVER SHEET
NO.	ISSUES REVISIONS	DATE

COVER SHEET

HL	PROJECT MANAGER
HL	PROJECT DIRECTOR
012317-1	PROJECT NUMBER
	SCALE
CL	DRAWN BY
	SHEET NUMBER

C-1

SYMBOLS LEGEND

RCP

- | | | | |
|--|--|--------------|--|
| | EXHAUST VENT | | TRACK LIGHT OR VANITY LIGHT |
| | CEILING MOUNTED LIGHT FIXTURE | | WALL-MOUNTED LIGHT FIXTURE |
| | CEILING MOUNTED DIRECTIONAL LIGHT | | EMERGENCY EXIT SIGN |
| | RECESSED CAN LIGHT | | EMERGENCY EXIT LIGHT |
| | EYEBALL OR SMALL CAN LIGHT | | EMERGENCY EXIT LIGHT W/ SIGN |
| | PENDANT LIGHT | | LIGHTED STAIR SIGN |
| | INDIVIDUAL FLUOR. LAY-IN FIXTURE 4 BULB | | FLOOD LIGHT |
| | INDIVIDUAL FLUOR. HANGING FIXTURE 2 BULB | | PHOTO CELL |
| | INDIVIDUAL FLUOR. FLUSH MOUNT FIXTURE 4 BULB | | CEILING FAN |
| | CAMERA | | CEILING FAN W/ LIGHT KIT |
| | MOTION DET. | | |
| | SUPPLY VENT | 7-2-6 | CEILING HEIGHT AND TRIM 7'-2" ABOVE FLOOR BELOW WITH 6" CROWN MOULDING. NOTE: ALL CEILING NOT LABELED ARE PLASTER. CEILING SHOWN WITH A GRID ARE LAY IN ACOUSTICAL TILE.. |
| | SUPPLY VENT | | JUNCTION BOX |
| | RETURN VENT | | |
| | RETURN VENT | | |
| | SPEAKER | | |

ELECTRIC

- | | |
|--|--------------------------------------|
| | DATA OUTLET |
| | TELEPHONE JACK |
| | ELECTRIC SWITCH |
| | CABLE TELEVISION OUTLET |
| | DUPLEX RECEPTACLE OUTLET |
| | SPECIAL PURPOSE CONNECTION OR OUTLET |
| | QUADRUPLEX RECEPTACLE OUTLET |
| | FLOOR DUPLEX RECEPTACLE OUTLET |
| | ELECTRIC PANEL |
| | ELECTRIC METER |
| | BUTTON SWITCH |
| | DISCONNECT SWITCH |
| | GROUND/FLOOR LIGHT |
| | KEY PAD |

FIRE PROTECTION




- | | |
|--|------------------------------|
| | FIRE EXTINGUISHER |
| | FIRE PULL |
| | FIRE ALARM (HORN/SRTOBE) |
| | SMOKE DETECTOR |
| | SMOKE ALARM SPEAKER |
| | SPRINKLER HEAD CEILING MOUNT |
| | SPRINKLER HEAD WALL MOUNT |

MEP

- | | |
|--|----------------------|
| | THERMOSTAT |
| | FLOOR DRAIN |
| | VALVE |
| | HOSE BIB |
| | WATER SUPPLY |
| | SUSPENDED GAS HEATER |

MISC

- | | |
|--|----------------|
| | BOLLARD |
| | SPOT ELEVATION |

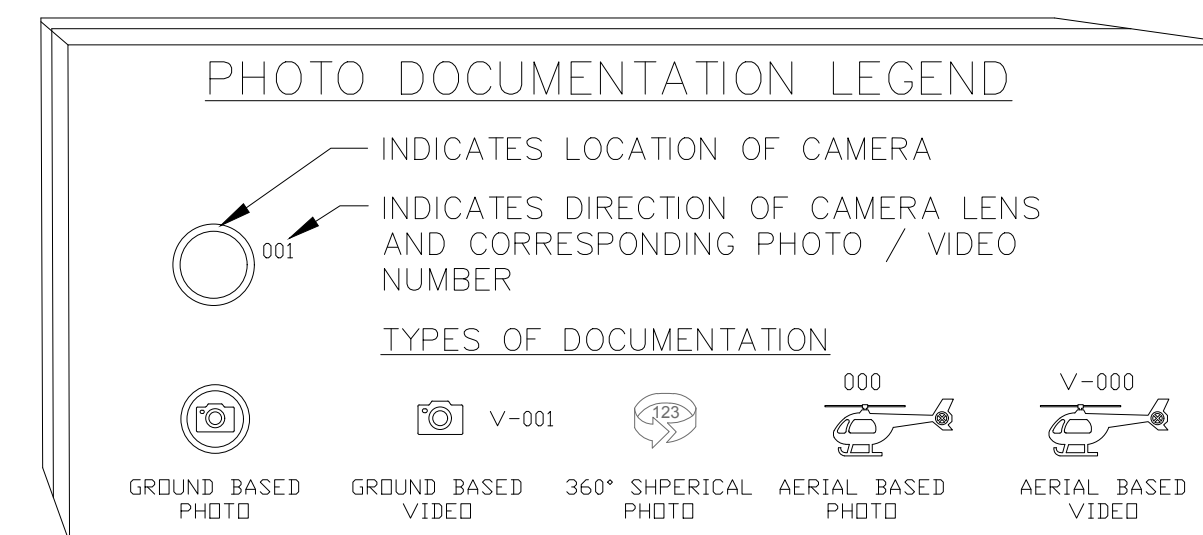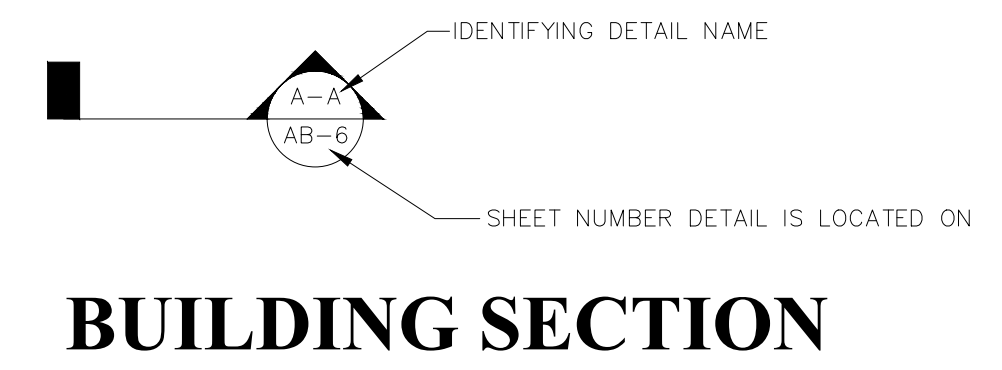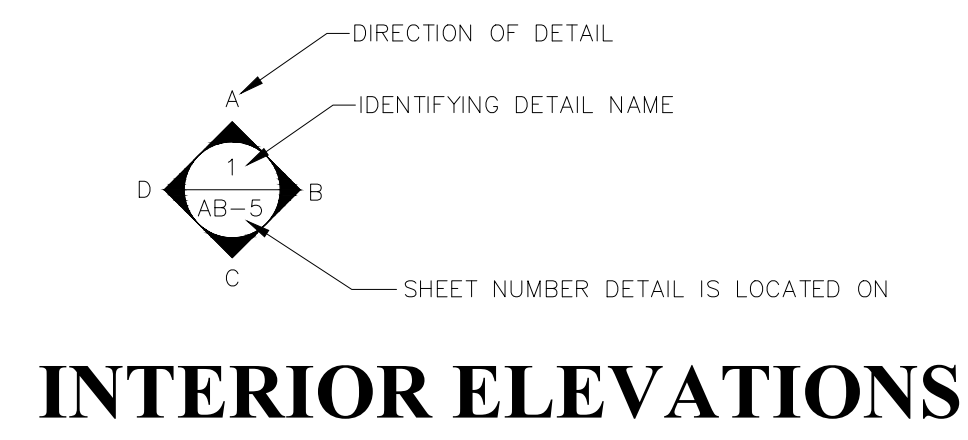

ARCHITECTURAL AS BUILT

Hixson, TN 37343

01	100% SUBMISSION	SEE COVER SHEET
NO.	ISSUES REVISIONS	DATE



SYMBOL LEGEND

HL	PROJECT MANAGER
HL	PROJECT DIRECTOR
012317-1	PROJECT NUMBER
1/4"=1'-0"	SCALE
CL	DRAWN BY
	SHEET NUMBER



SL

ARCHITECTURAL AS BUILT

Hixson, TN 37343

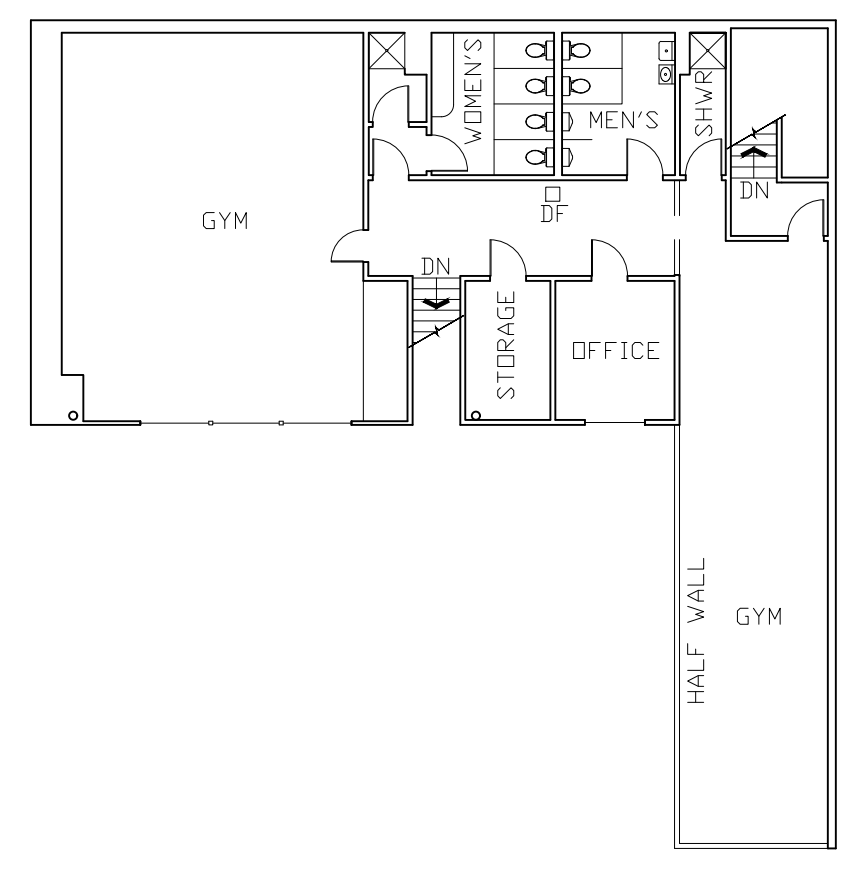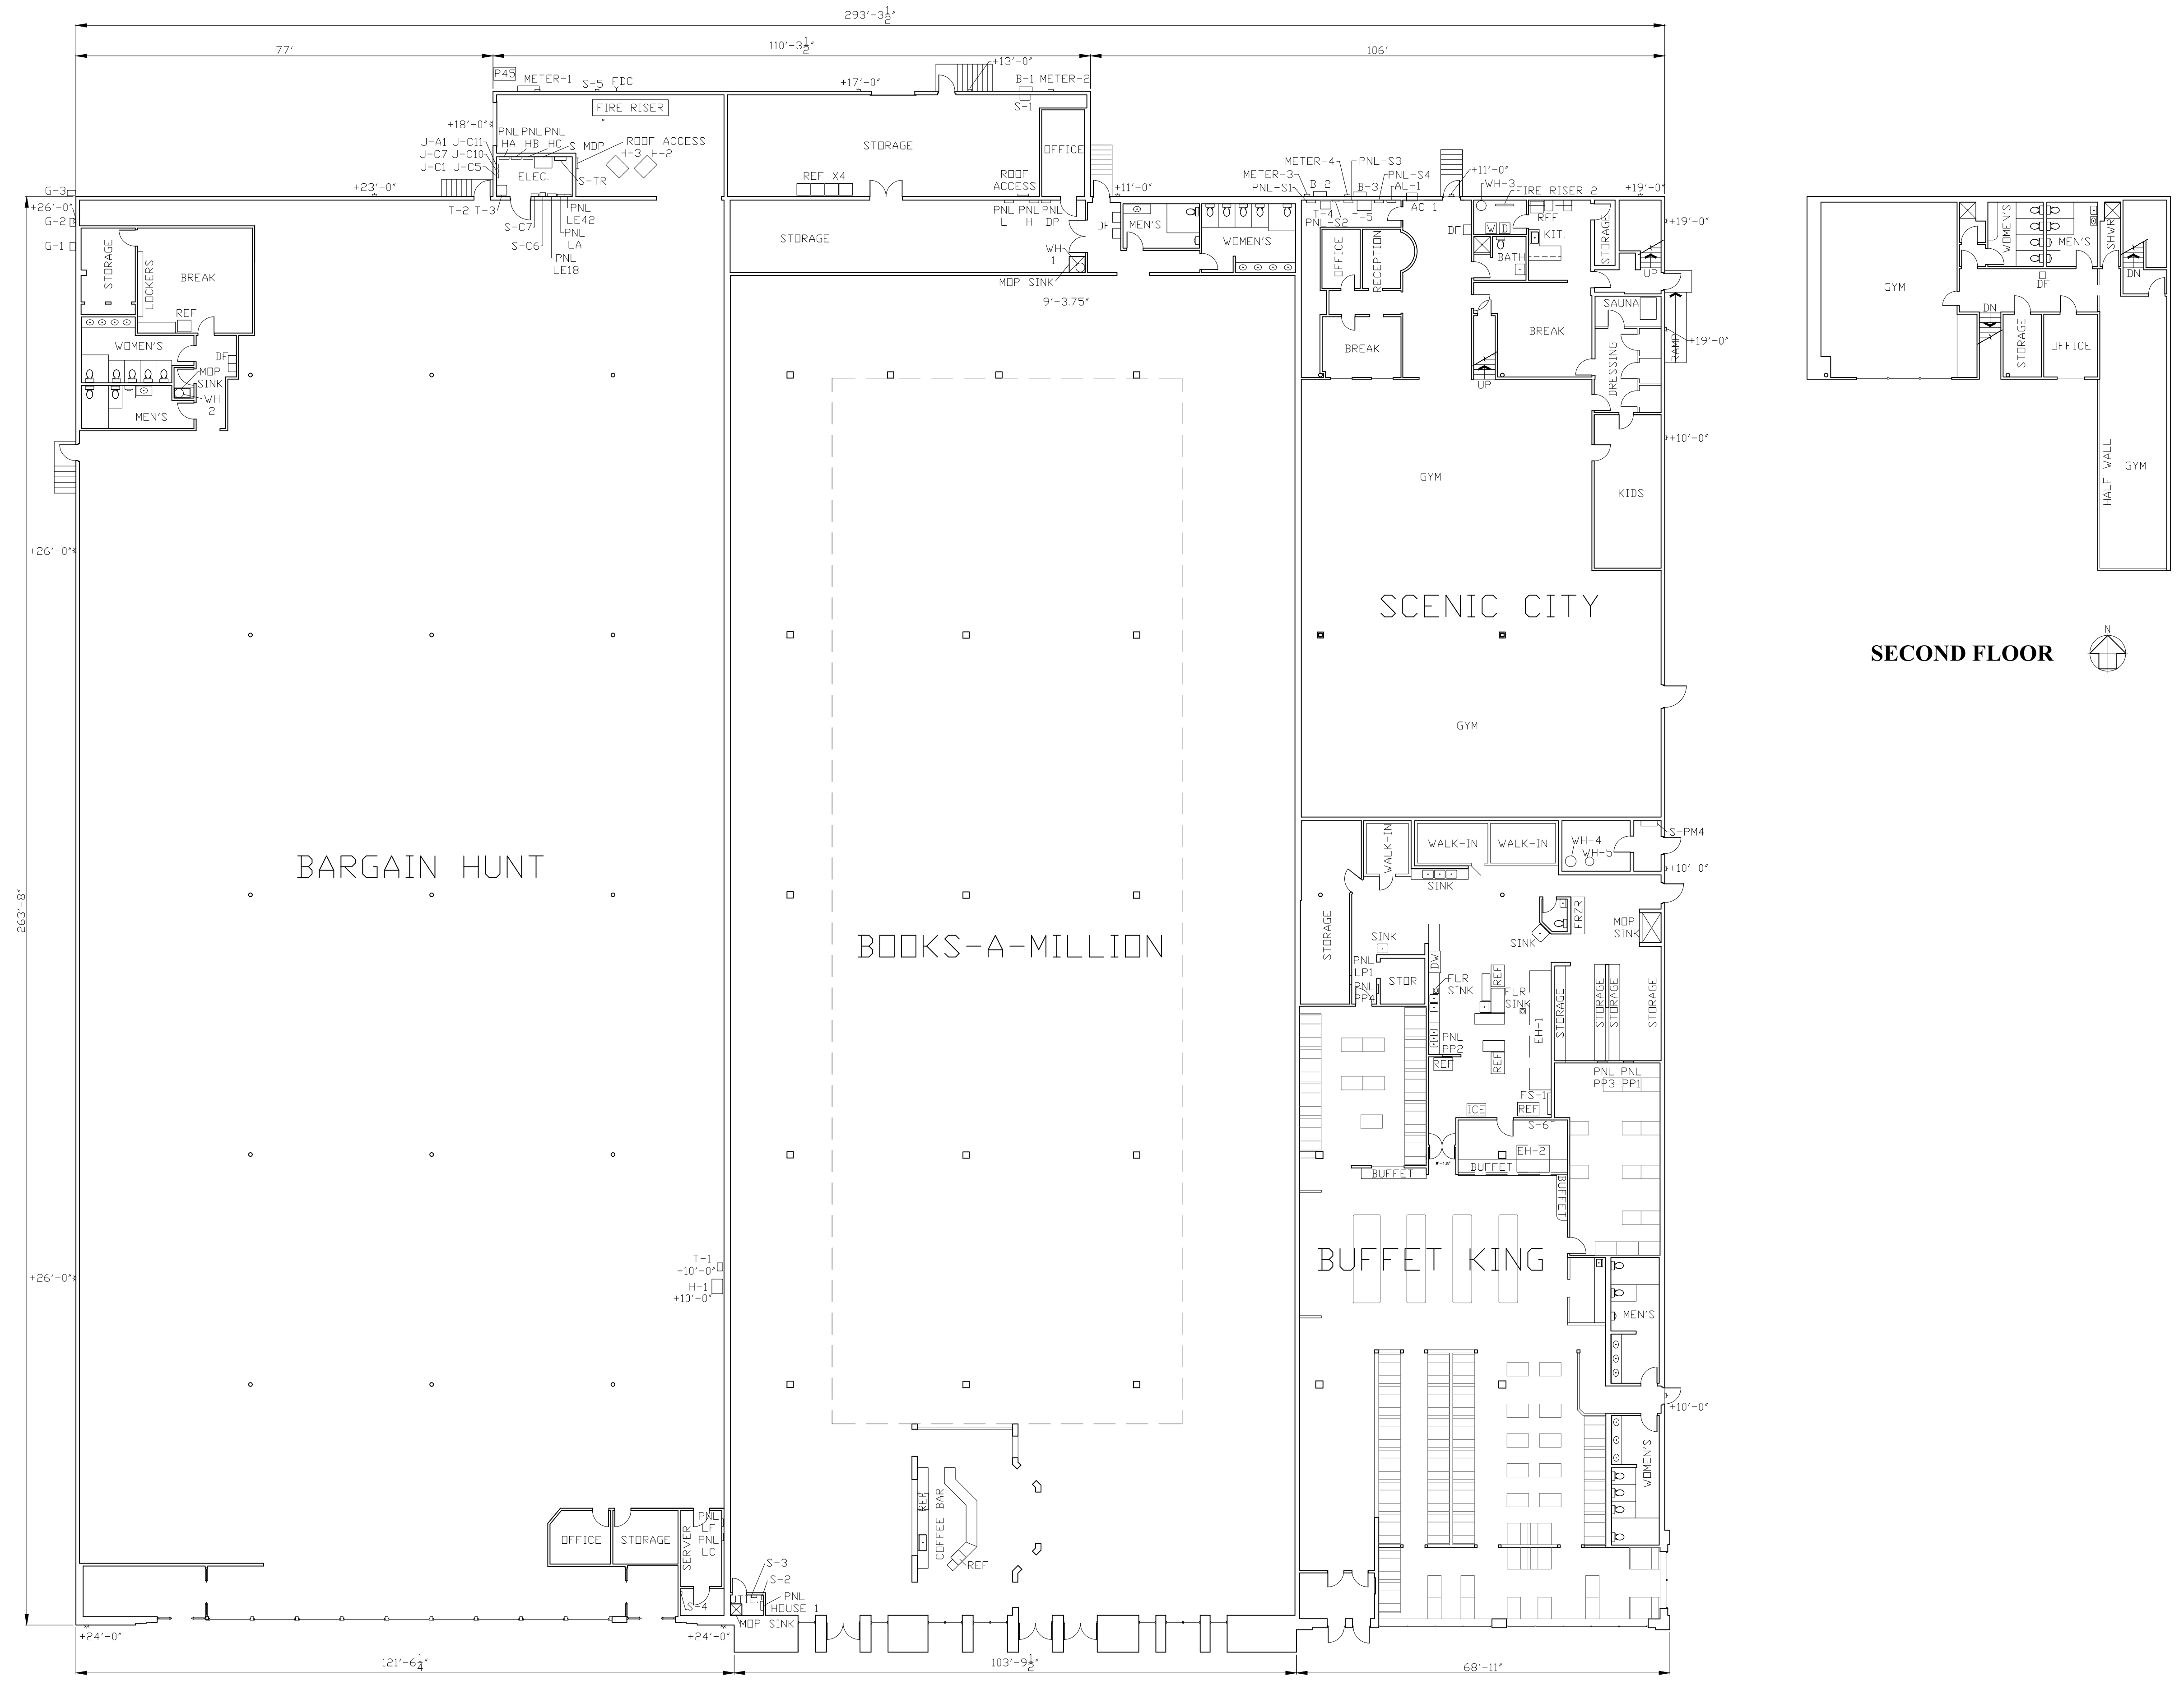


SECOND FLOOR

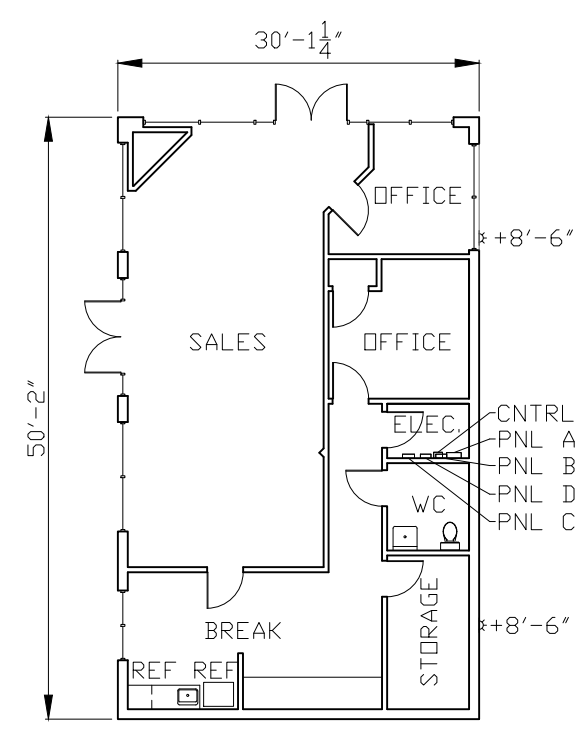 

ACCESSORY BUILDING

FLOOR PLAN

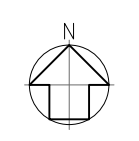

01	100% SUBMISSION	SEE COVER SHEET
NO.	ISSUES REVISIONS	DATE


FLOOR PLAN

HL	PROJECT MANAGER
HL	PROJECT DIRECTOR
012317-1	PROJECT NUMBER
1/16"=1'-0"	SCALE
CL	DRAWN BY
	SHEET NUMBER


AB-1

ARCHITECTURAL AS BUILT

Hixson, TN 37343

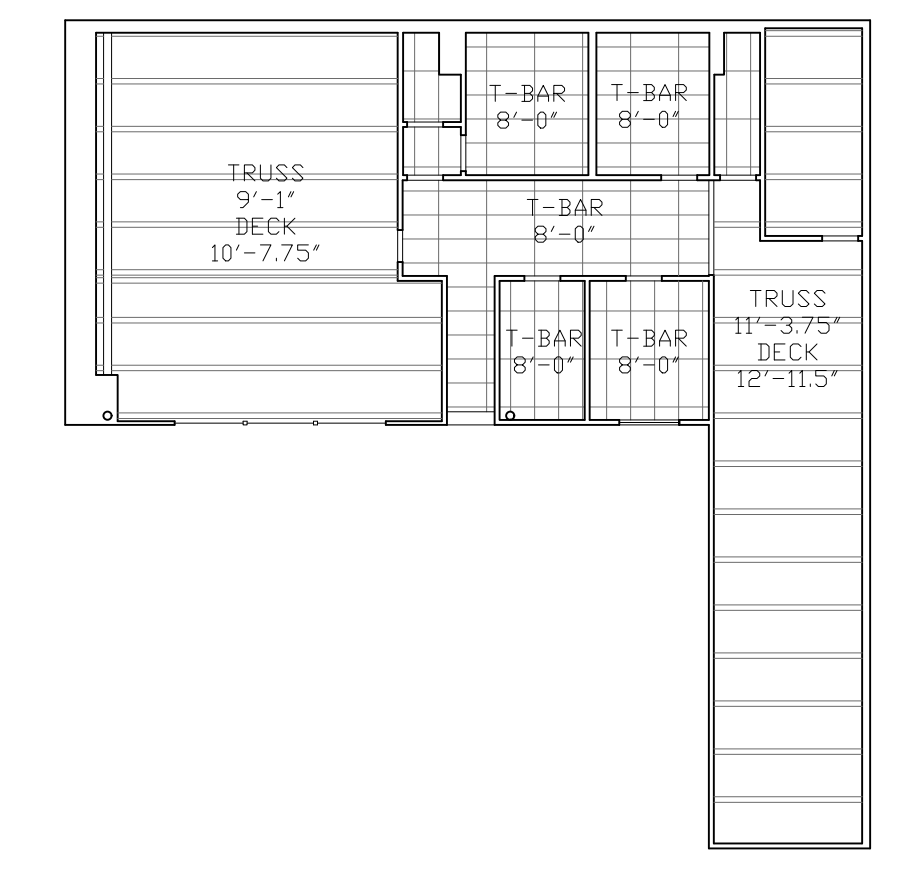

SECOND FLOOR

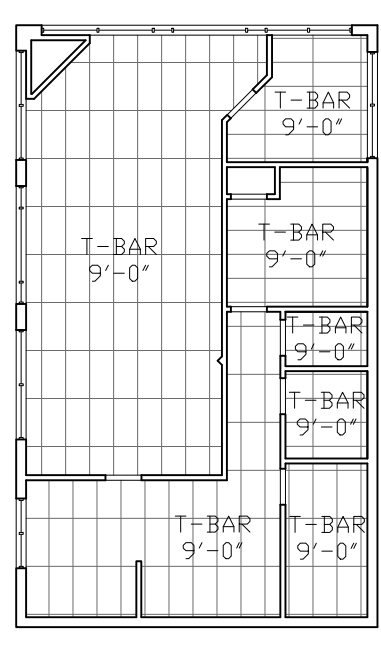

ACCESSORY BUILDING

REFLECTED CEILING PLAN

01	100% SUBMISSION	SEE COVER SHEET
NO.	ISSUES REVISIONS	DATE
		SHEET TITLE



REFLECTED CEILING PLANS

HL	PROJECT MANAGER
HL	PROJECT DIRECTOR
012317-1	PROJECT NUMBER
1/16"=1'-0"	SCALE
CL	DRAWN BY
	SHEET NUMBER

AB-2

ARCHITECTURAL AS BUILT

Hixson, TN 37343

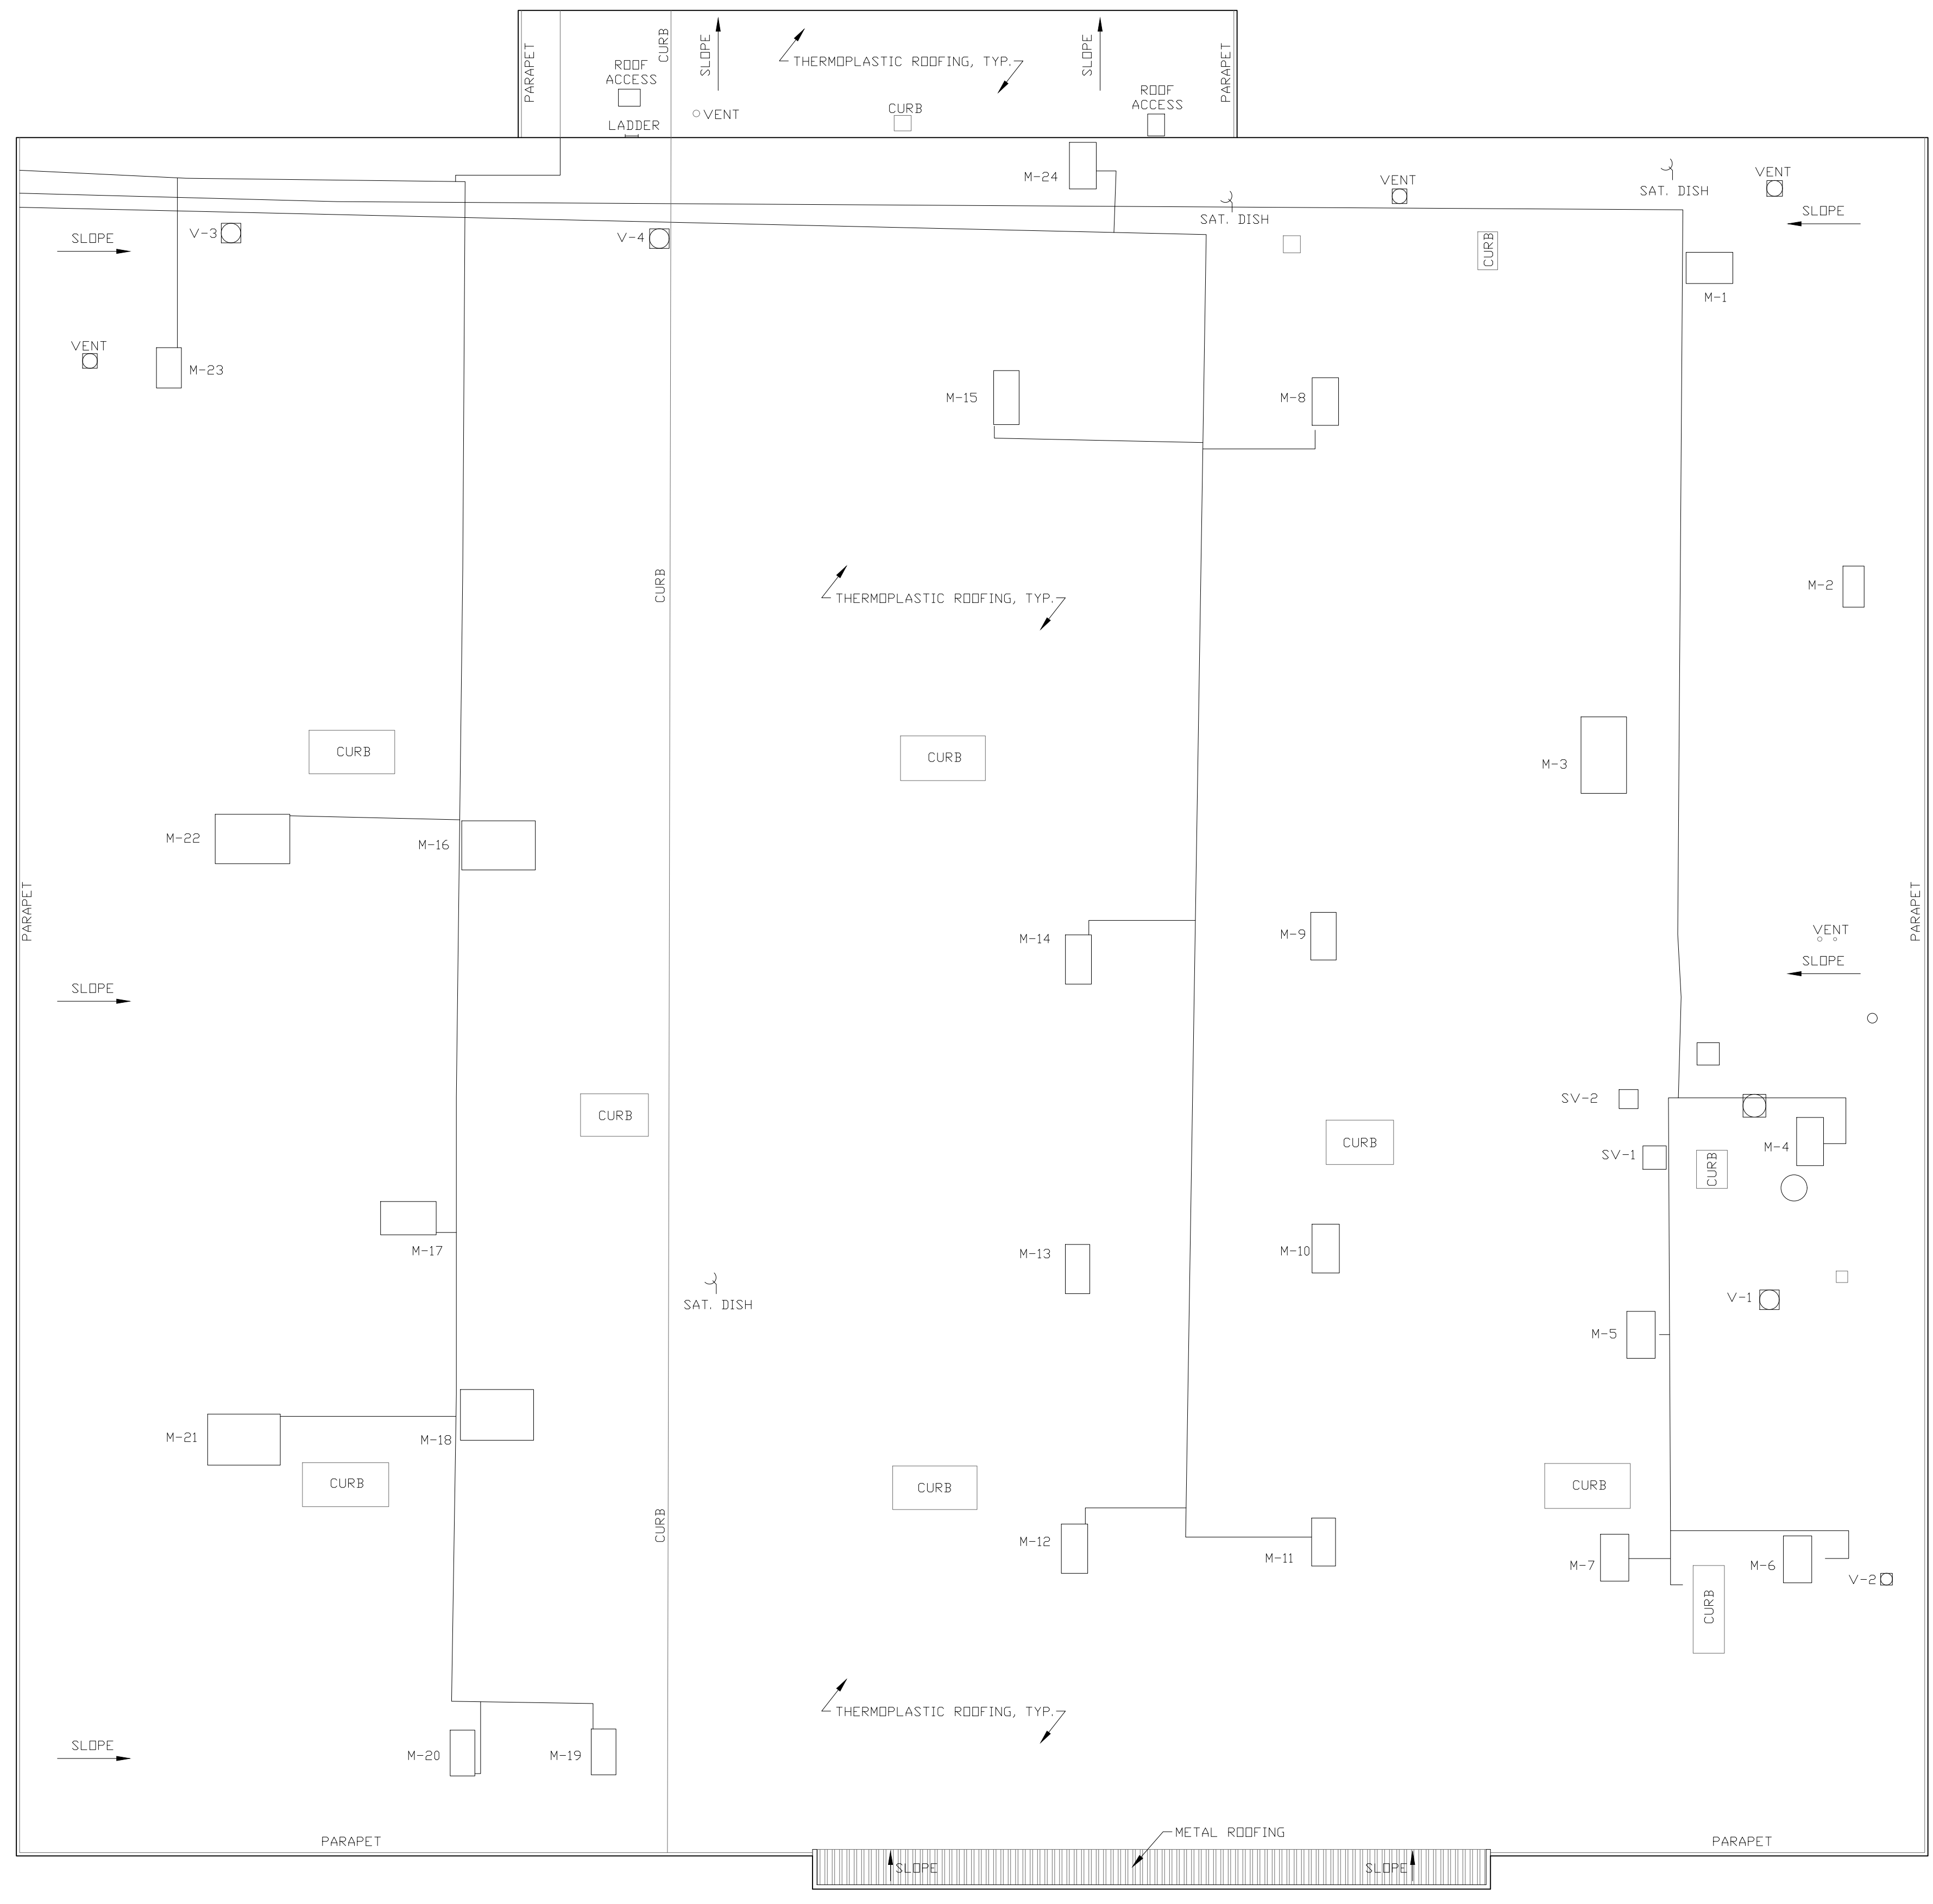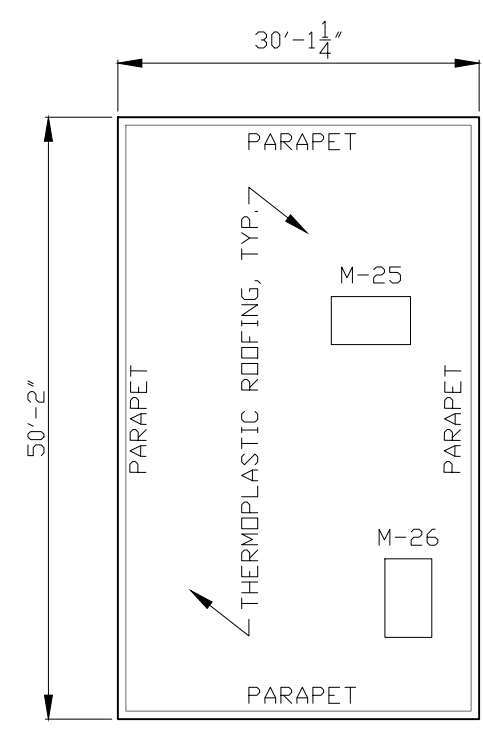

ACCESSORY BUILDING

ROOF PLAN

01	100% SUBMISSION	SEE COVER SHEET
NO.	ISSUES REVISIONS	DATE

SHEET TITLE

ROOF PLAN

HL	PROJECT MANAGER
HL	PROJECT DIRECTOR
012317-1	PROJECT NUMBER
1/16"=1'-0"	SCALE
CL	DRAWN BY
	SHEET NUMBER

AB-3