

 
GUEST ROOM SUMMARY AND LOCATION			
ROOM TYPE A		ROOM TYPE B	ROOM TYPE C
A X05 A - QTY: 10 (305-1205)	A-6 X07 A-6 - QTY: 1 (1407)	B X01 B - QTY: 9 (301-1101)	C X06 C - QTY: 11 (306-1406)
A-M X07 A - QTY: 10 (307-1207)	A-6M X05 A-6 - QTY: 1 (1405)	B-1 X02 B-1 - QTY: 9 (302-1102)	C-1 X08 C-1 - QTY: 11 (308-1408)
A-1 X04 A-1 - QTY: 10 (304-1204)	A-7 X09 A-7 - QTY: 1 (1409)	B-2 X03 B-2 - QTY: 9 (303-1103)	C-2 X10 C-2 - QTY: 11 (310-1410)
A-2 X09 A-2 - ADA - QTY: 6 (409-909)	A-8 X02 A-8 - QTY: 1 (202)	B-3 X11 B-3 - QTY: 11 (311-1411)	C-3 X04 C-3 - QTY: 1 (1404)
A-3 X09 A-3 - QTY: 3 (1009-1209)	A-9 X02 PRES. SUITE A-9 - QTY: 1 (1201/1202)	B-4 X15 B-4 - QTY: 11 (315-1415)	
A-4 X12 A-4 - QTY: 11 (312-1412)	A-10 X02 PRES. SUITE A-10 - QTY: 1 (1401/1402)	B-5 X01 B-5 ADA - QTY: 1 (201)	
A-5 X13 A-5 - QTY: 11 ROOMS (313-1413)	A-11 X09 A-11 - ADA - QTY: 1 (309)	B-6 X03 B-6 - QTY: 2 (1203 & 1403)	
A-5M X14 A-5 - QTY: 11 ROOMS (314-1414)			

SYMBOLS LEGEND																																																																																																																									
RCP <table> <tr> <td></td> <td>EXHAUST VENT</td> <td></td> <td>TRACK LIGHT OR VANITY LIGHT</td> </tr> <tr> <td></td> <td>CEILING MOUNTED LIGHT FIXTURE</td> <td></td> <td>HALL-MOUNTED LIGHT FIXTURE</td> </tr> <tr> <td></td> <td>CEILING MOUNTED DIRECTIONAL LIGHT</td> <td></td> <td>EMERGENCY EXIT SIGN</td> </tr> <tr> <td></td> <td>RECESSED CAN LIGHT</td> <td></td> <td>EMERGENCY EXIT LIGHT</td> </tr> <tr> <td></td> <td>EYEBALL OR SMALL CAN LIGHT</td> <td></td> <td>EMERGENCY EXIT LIGHT W/ SIGN</td> </tr> <tr> <td></td> <td>PENDANT LIGHT</td> <td></td> <td>LIGHTED STAIR SIGN</td> </tr> <tr> <td></td> <td>INDIVIDUAL FLOOR LAY-IN FIXTURE 4 BULB</td> <td></td> <td>FLOOD LIGHT</td> </tr> <tr> <td></td> <td>INDIVIDUAL FLOOR HANGING FIXTURE 2 BULB</td> <td></td> <td>PHOTO CELL</td> </tr> <tr> <td></td> <td>INDIVIDUAL FLOOR FLUSH MOUNT FIXTURE 4 BULB</td> <td></td> <td>CEILING FAN</td> </tr> <tr> <td></td> <td>CAMERA</td> <td></td> <td>CEILING FAN W/ LIGHT KIT</td> </tr> <tr> <td></td> <td>MOTION DET.</td> <td></td> <td>CEILING HEIGHT AND TRIM</td> </tr> <tr> <td></td> <td>SUPPLY VENT</td> <td></td> <td>7-2-6</td> </tr> <tr> <td></td> <td>SUPPLY VENT</td> <td></td> <td></td> </tr> <tr> <td></td> <td>RETURN VENT</td> <td></td> <td></td> </tr> <tr> <td></td> <td>RETURN VENT</td> <td></td> <td></td> </tr> <tr> <td></td> <td>SPEAKER</td> <td></td> <td></td> </tr> </table>		EXHAUST VENT		TRACK LIGHT OR VANITY LIGHT		CEILING MOUNTED LIGHT FIXTURE		HALL-MOUNTED LIGHT FIXTURE		CEILING MOUNTED DIRECTIONAL LIGHT		EMERGENCY EXIT SIGN		RECESSED CAN LIGHT		EMERGENCY EXIT LIGHT		EYEBALL OR SMALL CAN LIGHT		EMERGENCY EXIT LIGHT W/ SIGN		PENDANT LIGHT		LIGHTED STAIR SIGN		INDIVIDUAL FLOOR LAY-IN FIXTURE 4 BULB		FLOOD LIGHT		INDIVIDUAL FLOOR HANGING FIXTURE 2 BULB		PHOTO CELL		INDIVIDUAL FLOOR FLUSH MOUNT FIXTURE 4 BULB		CEILING FAN		CAMERA		CEILING FAN W/ LIGHT KIT		MOTION DET.		CEILING HEIGHT AND TRIM		SUPPLY VENT		7-2-6		SUPPLY VENT				RETURN VENT				RETURN VENT				SPEAKER			ELECTRIC <table> <tr> <td></td> <td>DATA OUTLET</td> <td></td> <td>FIRE EXTINGUISHER</td> </tr> <tr> <td></td> <td>TELEPHONE JACK</td> <td></td> <td>FIRE PULL</td> </tr> <tr> <td></td> <td>ELECTRIC SWITCH</td> <td></td> <td>FIRE ALARM (HORN/SRT/COB)</td> </tr> <tr> <td></td> <td>CABLE TELEVISION OUTLET</td> <td></td> <td>SMOKE DETECTOR</td> </tr> <tr> <td></td> <td>DUPLEX RECEPTACLE OUTLET</td> <td></td> <td>SMOKE ALARM SPEAKER</td> </tr> <tr> <td></td> <td>SPECIAL PURPOSE CONNECTION OR OUTLET</td> <td></td> <td>SPRINKLER HEAD CEILING MOUNT</td> </tr> <tr> <td></td> <td>QUADPLEX RECEPTACLE OUTLET</td> <td></td> <td>SPRINKLER HEAD WALL MOUNT</td> </tr> <tr> <td></td> <td>FLOOR DUPLEX RECEPTACLE OUTLET</td> <td></td> <td></td> </tr> <tr> <td></td> <td>ELECTRIC PANEL</td> <td></td> <td></td> </tr> <tr> <td></td> <td>ELECTRIC METER</td> <td></td> <td></td> </tr> <tr> <td></td> <td>BUTTON SWITCH</td> <td></td> <td></td> </tr> <tr> <td></td> <td>DISCONNECT SWITCH</td> <td></td> <td></td> </tr> <tr> <td></td> <td>GROUND/FLOOR LIGHT</td> <td></td> <td></td> </tr> <tr> <td></td> <td>KEY PAD</td> <td></td> <td></td> </tr> </table>		DATA OUTLET		FIRE EXTINGUISHER		TELEPHONE JACK		FIRE PULL		ELECTRIC SWITCH		FIRE ALARM (HORN/SRT/COB)		CABLE TELEVISION OUTLET		SMOKE DETECTOR		DUPLEX RECEPTACLE OUTLET		SMOKE ALARM SPEAKER		SPECIAL PURPOSE CONNECTION OR OUTLET		SPRINKLER HEAD CEILING MOUNT		QUADPLEX RECEPTACLE OUTLET		SPRINKLER HEAD WALL MOUNT		FLOOR DUPLEX RECEPTACLE OUTLET				ELECTRIC PANEL				ELECTRIC METER				BUTTON SWITCH				DISCONNECT SWITCH				GROUND/FLOOR LIGHT				KEY PAD		
	EXHAUST VENT		TRACK LIGHT OR VANITY LIGHT																																																																																																																						
	CEILING MOUNTED LIGHT FIXTURE		HALL-MOUNTED LIGHT FIXTURE																																																																																																																						
	CEILING MOUNTED DIRECTIONAL LIGHT		EMERGENCY EXIT SIGN																																																																																																																						
	RECESSED CAN LIGHT		EMERGENCY EXIT LIGHT																																																																																																																						
	EYEBALL OR SMALL CAN LIGHT		EMERGENCY EXIT LIGHT W/ SIGN																																																																																																																						
	PENDANT LIGHT		LIGHTED STAIR SIGN																																																																																																																						
	INDIVIDUAL FLOOR LAY-IN FIXTURE 4 BULB		FLOOD LIGHT																																																																																																																						
	INDIVIDUAL FLOOR HANGING FIXTURE 2 BULB		PHOTO CELL																																																																																																																						
	INDIVIDUAL FLOOR FLUSH MOUNT FIXTURE 4 BULB		CEILING FAN																																																																																																																						
	CAMERA		CEILING FAN W/ LIGHT KIT																																																																																																																						
	MOTION DET.		CEILING HEIGHT AND TRIM																																																																																																																						
	SUPPLY VENT		7-2-6																																																																																																																						
	SUPPLY VENT																																																																																																																								
	RETURN VENT																																																																																																																								
	RETURN VENT																																																																																																																								
	SPEAKER																																																																																																																								
	DATA OUTLET		FIRE EXTINGUISHER																																																																																																																						
	TELEPHONE JACK		FIRE PULL																																																																																																																						
	ELECTRIC SWITCH		FIRE ALARM (HORN/SRT/COB)																																																																																																																						
	CABLE TELEVISION OUTLET		SMOKE DETECTOR																																																																																																																						
	DUPLEX RECEPTACLE OUTLET		SMOKE ALARM SPEAKER																																																																																																																						
	SPECIAL PURPOSE CONNECTION OR OUTLET		SPRINKLER HEAD CEILING MOUNT																																																																																																																						
	QUADPLEX RECEPTACLE OUTLET		SPRINKLER HEAD WALL MOUNT																																																																																																																						
	FLOOR DUPLEX RECEPTACLE OUTLET																																																																																																																								
	ELECTRIC PANEL																																																																																																																								
	ELECTRIC METER																																																																																																																								
	BUTTON SWITCH																																																																																																																								
	DISCONNECT SWITCH																																																																																																																								
	GROUND/FLOOR LIGHT																																																																																																																								
	KEY PAD																																																																																																																								
	FIRE PROTECTION <table> <tr> <td></td> <td>FIRE EXTINGUISHER</td> </tr> <tr> <td></td> <td>FIRE PULL</td> </tr> <tr> <td></td> <td>FIRE ALARM (HORN/SRT/COB)</td> </tr> <tr> <td></td> <td>SMOKE DETECTOR</td> </tr> <tr> <td></td> <td>SMOKE ALARM SPEAKER</td> </tr> <tr> <td></td> <td>SPRINKLER HEAD CEILING MOUNT</td> </tr> <tr> <td></td> <td>SPRINKLER HEAD WALL MOUNT</td> </tr> </table>		FIRE EXTINGUISHER		FIRE PULL		FIRE ALARM (HORN/SRT/COB)		SMOKE DETECTOR		SMOKE ALARM SPEAKER		SPRINKLER HEAD CEILING MOUNT		SPRINKLER HEAD WALL MOUNT																																																																																																										
	FIRE EXTINGUISHER																																																																																																																								
	FIRE PULL																																																																																																																								
	FIRE ALARM (HORN/SRT/COB)																																																																																																																								
	SMOKE DETECTOR																																																																																																																								
	SMOKE ALARM SPEAKER																																																																																																																								
	SPRINKLER HEAD CEILING MOUNT																																																																																																																								
	SPRINKLER HEAD WALL MOUNT																																																																																																																								
	MEP <table> <tr> <td></td> <td>THERMOSTAT</td> </tr> <tr> <td></td> <td>FLOOR DRAIN</td> </tr> <tr> <td></td> <td>VALVE</td> </tr> <tr> <td></td> <td>HOSE BIB</td> </tr> <tr> <td></td> <td>WATER SUPPLY</td> </tr> <tr> <td></td> <td>SUSPENDED GAS HEATER</td> </tr> </table>		THERMOSTAT		FLOOR DRAIN		VALVE		HOSE BIB		WATER SUPPLY		SUSPENDED GAS HEATER																																																																																																												
	THERMOSTAT																																																																																																																								
	FLOOR DRAIN																																																																																																																								
	VALVE																																																																																																																								
	HOSE BIB																																																																																																																								
	WATER SUPPLY																																																																																																																								
	SUSPENDED GAS HEATER																																																																																																																								
	MISC <table> <tr> <td></td> <td>BOLLARD</td> </tr> </table>		BOLLARD																																																																																																																						
	BOLLARD																																																																																																																								



CHICAGO, IL 60610

L-1




SHEET TITLE

HL	PROJECT DIRECTOR
----	------------------


AS NOTED SCALE

APP. 1 SHEET NUMBER

 ET NUMBER



ABR-1

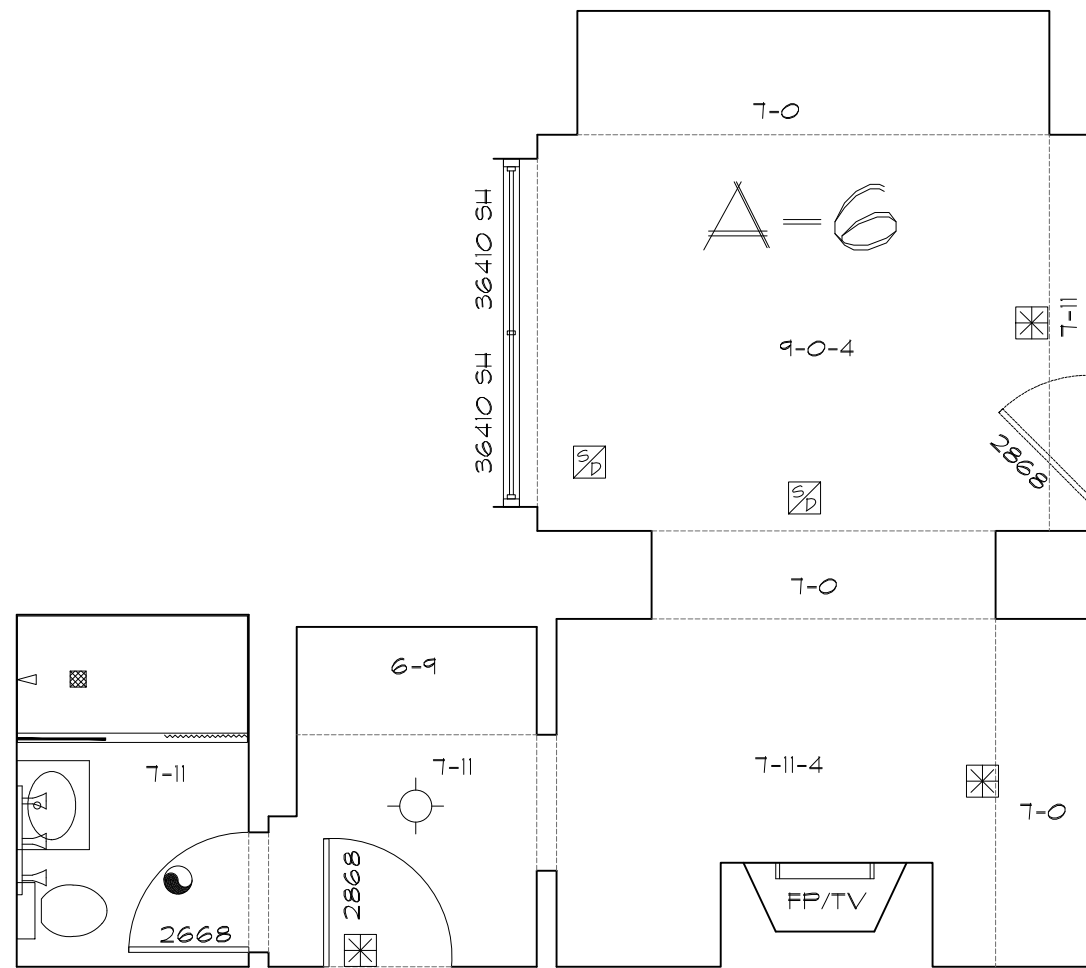


A-6
X07

A-6 - QTY: 1 (1407)




A-6M
X05

A-6 - QTY: 1 (1405)

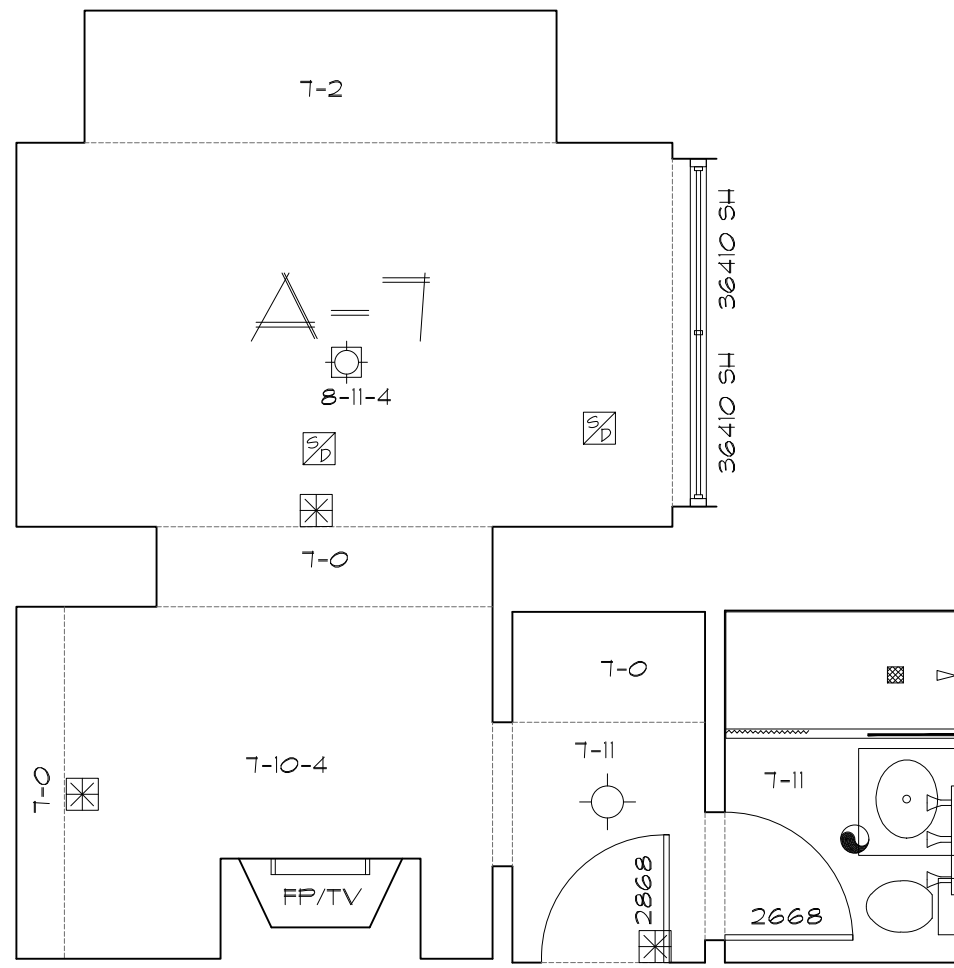


A-7
X09

A-7 - QTY: 1 (1409)

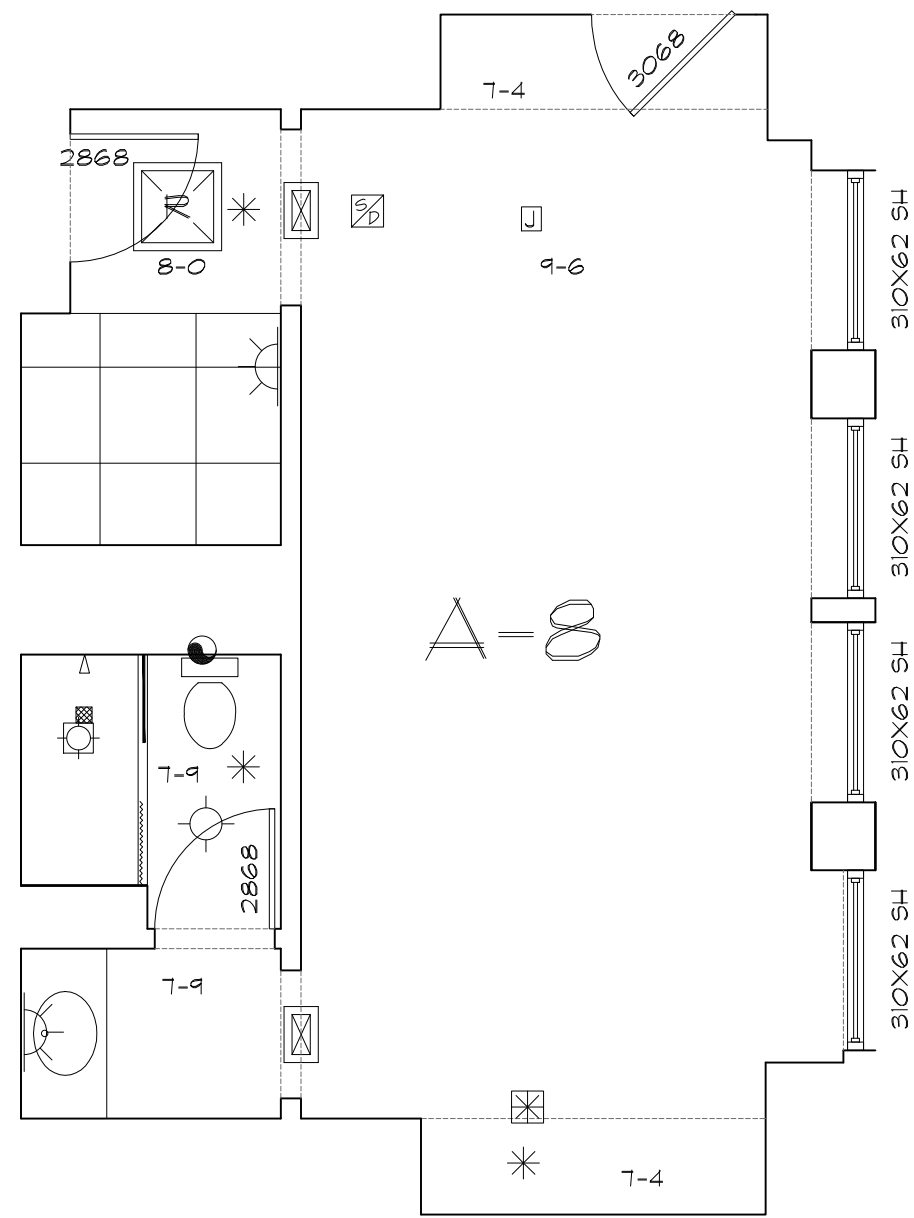


A-8
X02

A-8 - QTY: 1 (202)

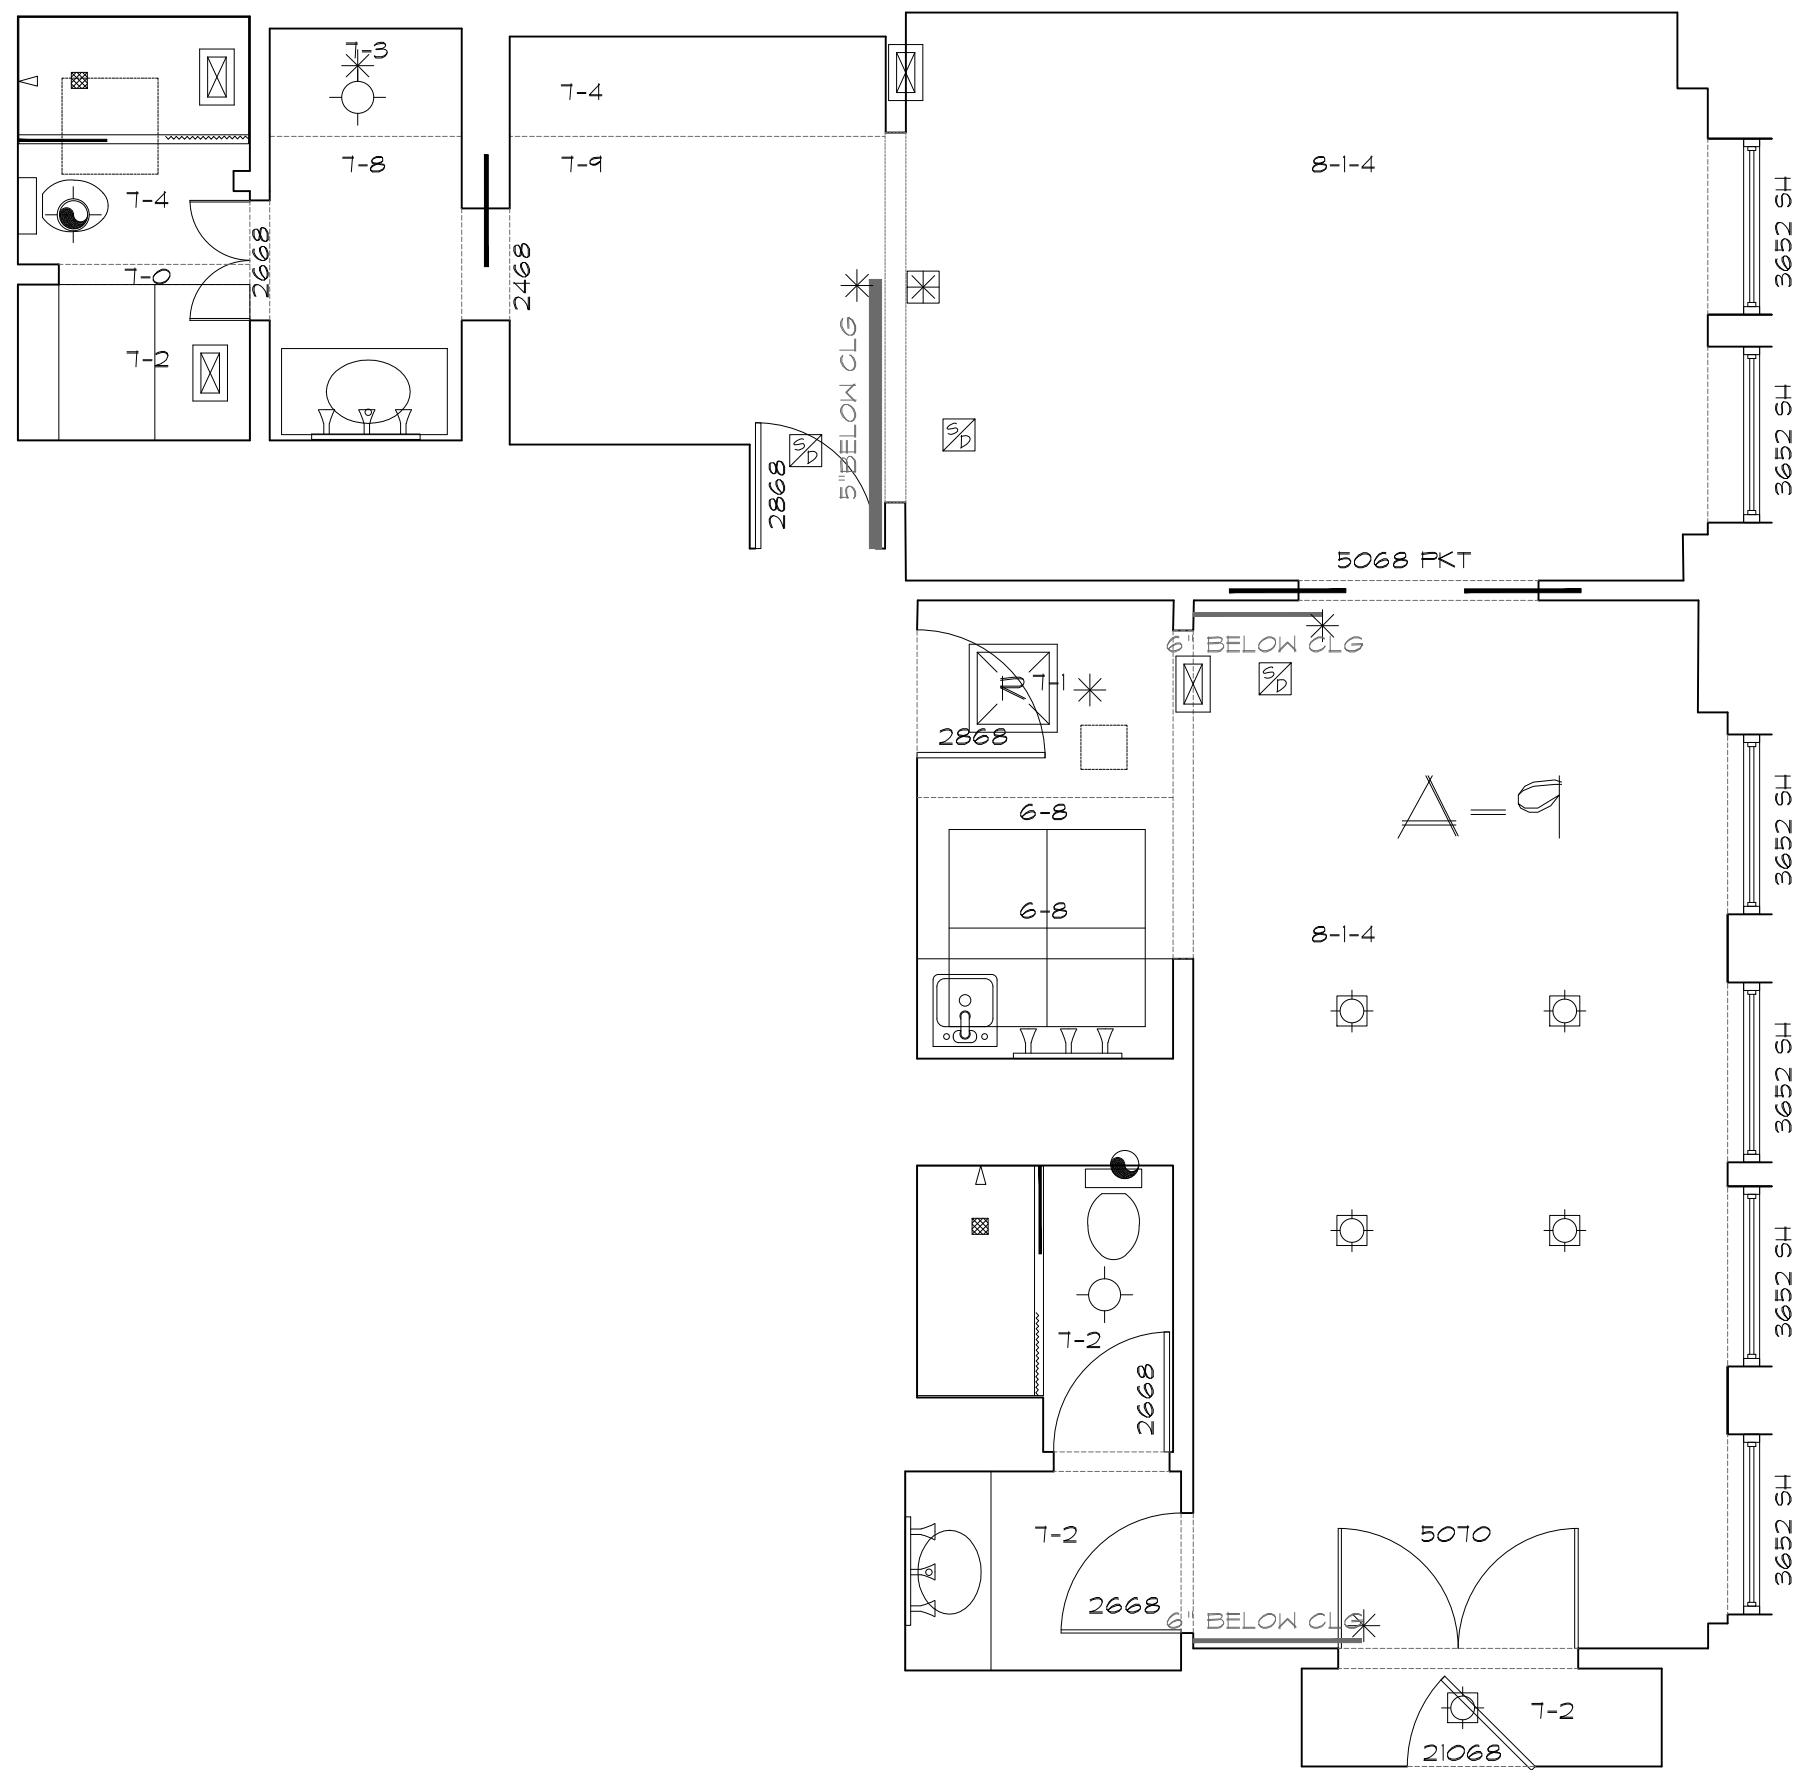


A-9
X02
PRES. SUITE

A-9 - QTY: 1 (1201/1202)

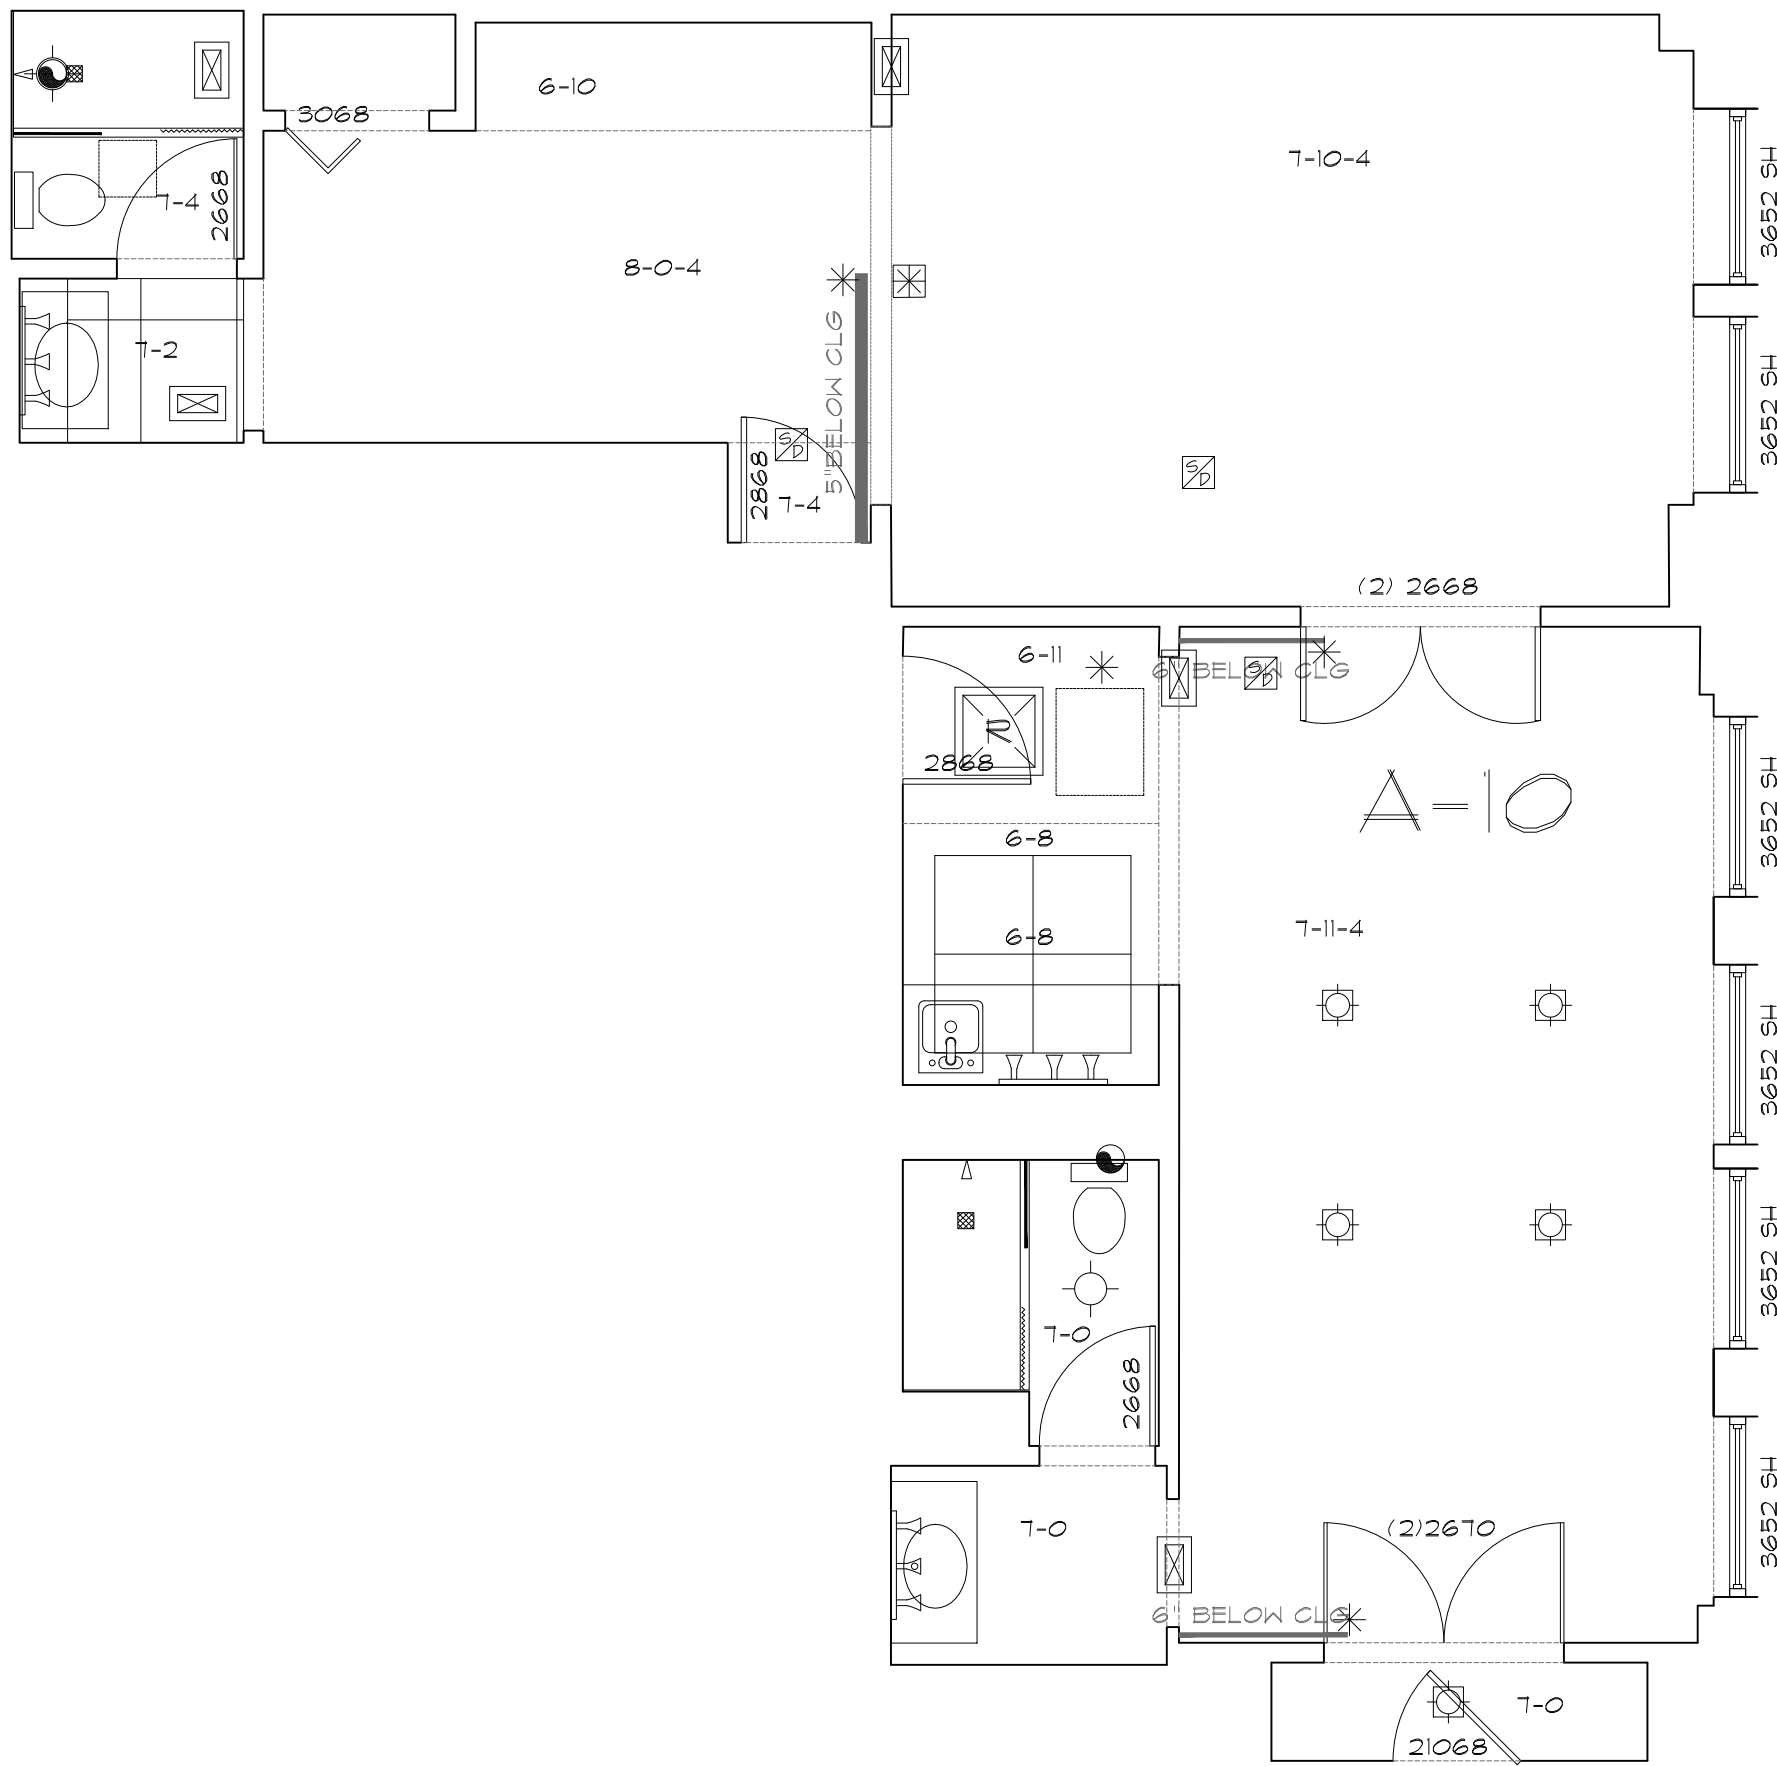

A-10
X02
PRES. SUITE

A-10 - QTY: 1 (1401/1402)

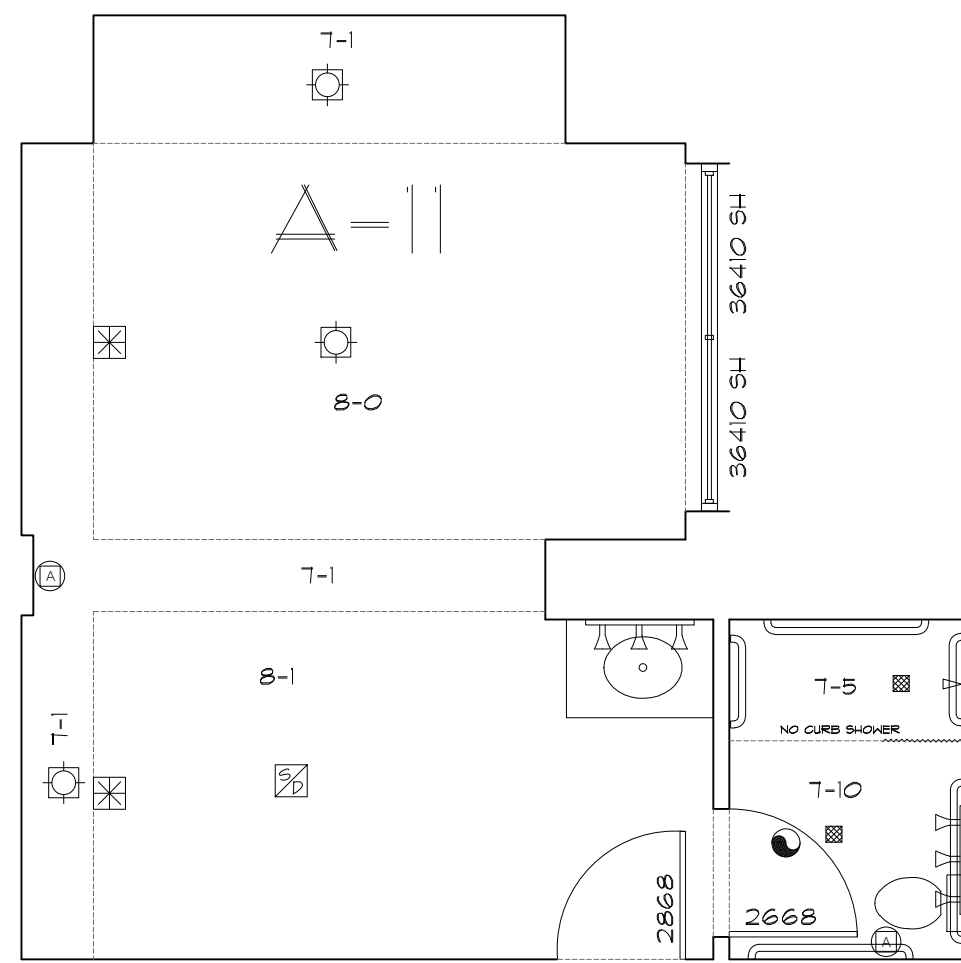

A-11
X09

A-11 - ADA - QTY: 1 (309)

AS BUILT
PROFESSIONALS
A DIVISION OF:

AEC
CONSULTANTS INC
www.aecconsultantsinc.com
844.272.8458


© 2016 AEC CONSULTANTS INC

ARCHITECTURAL AS BUILT
HOTEL INDIGO
CHICAGO, IL 60610

01	100% SUBMISSION	
NO.	ISSUES REVISIONS	DATE
		SHEET TITLE
HL	PROJECT MANAGER	
HL	PROJECT DIRECTOR	
9-2-16-1	PROJECT NUMBER	
AS NOTED	SCALE	
CL	DRAWN BY	
		SHEET NUMBER


ABR-2

ROOM LAYOUTS 1/4"=1'-0"

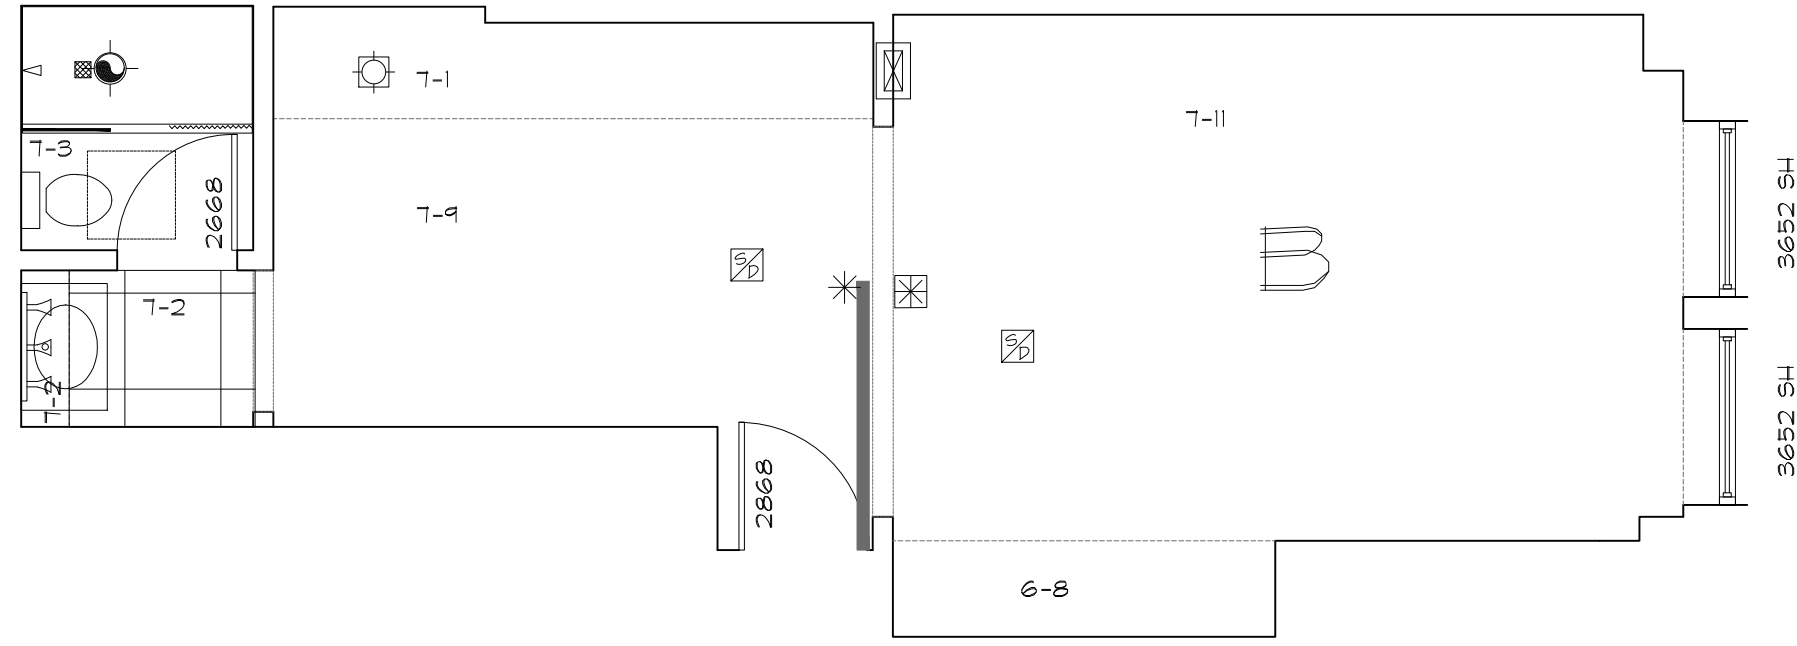


B
X01

B - QTY: 9 (301-1101)

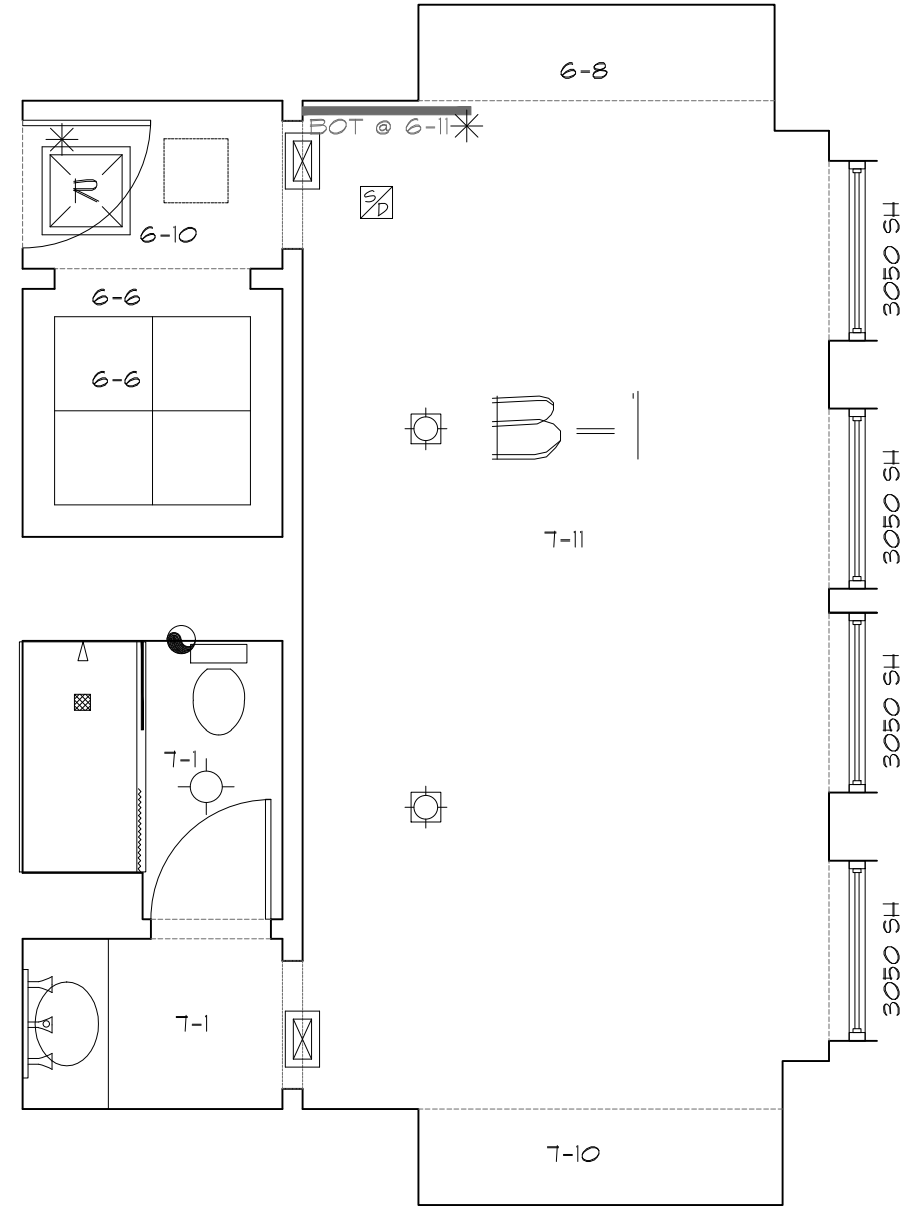


B-1
X02

B-1 - QTY: 9 (302-1102)

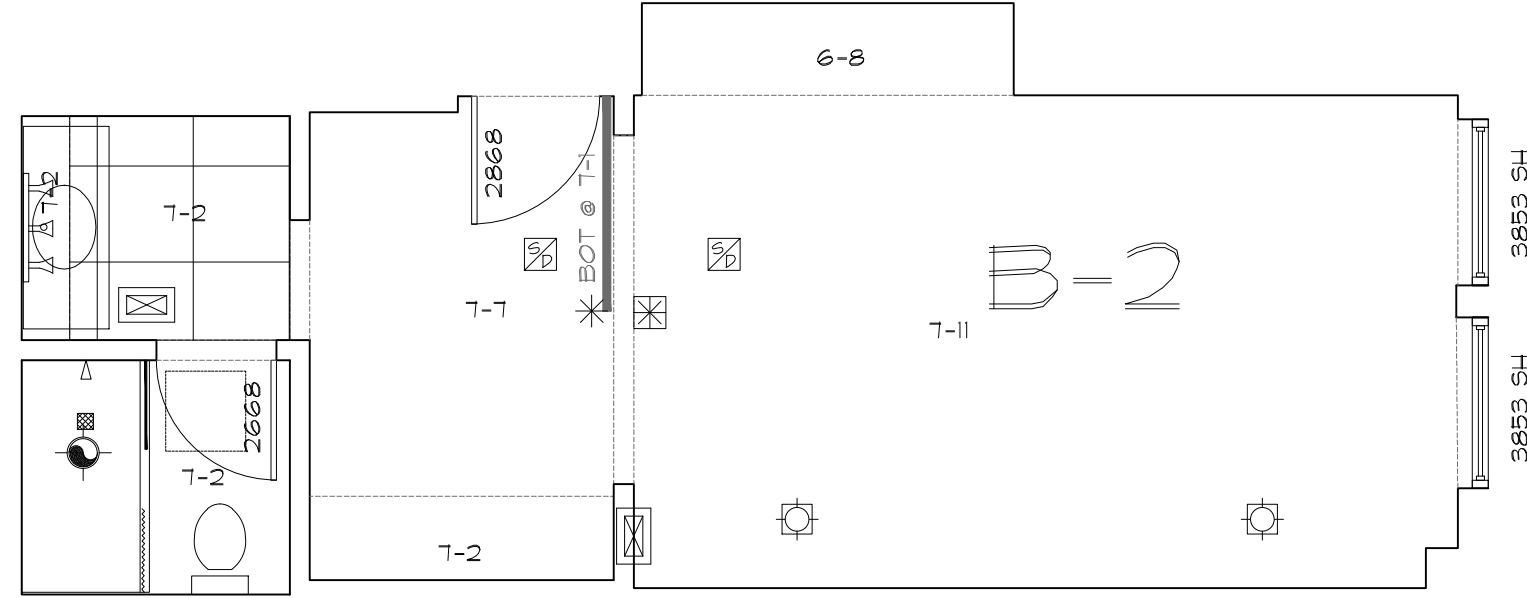


B-2
X03

B-2 - QTY: 9 (303-1103)

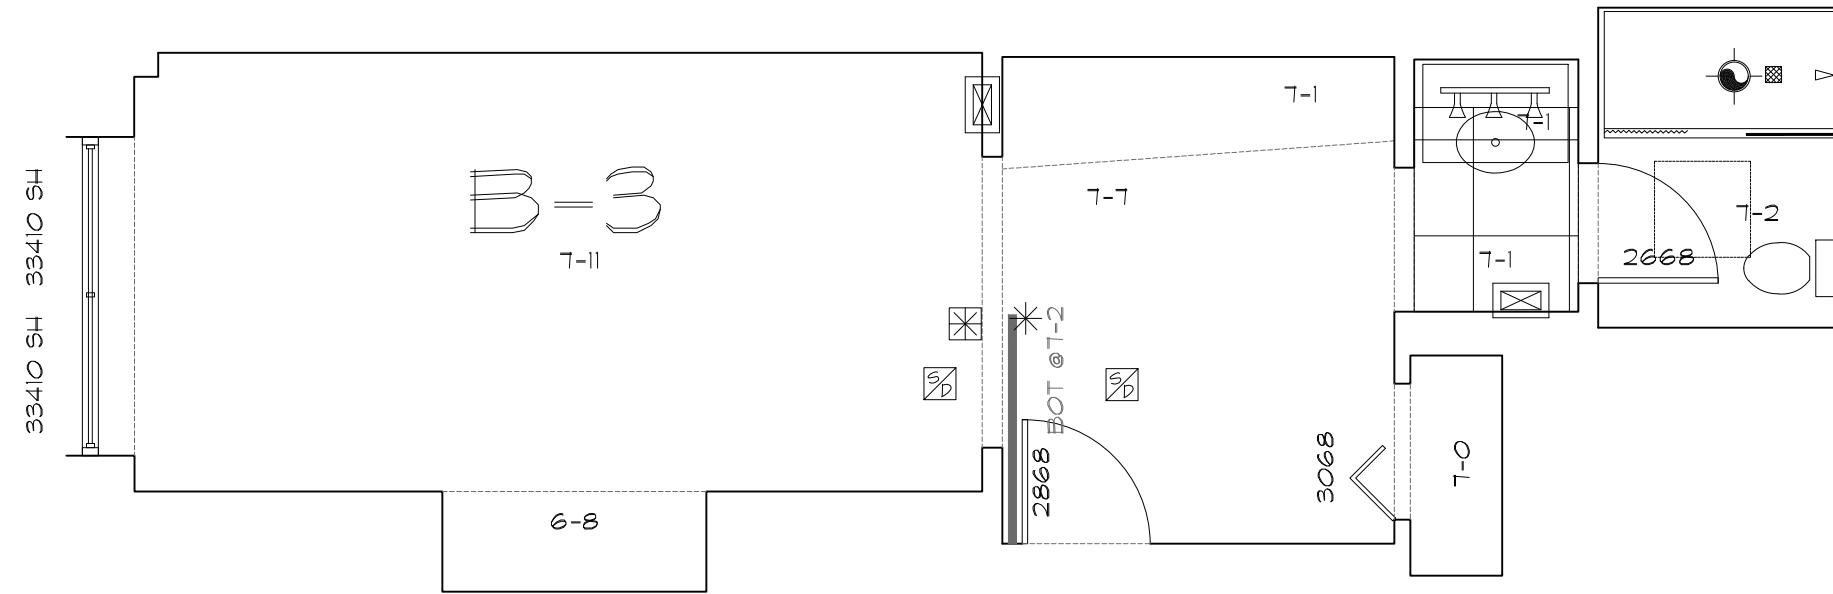

B-3
X11

B-3 - QTY: 11 (311-1411)

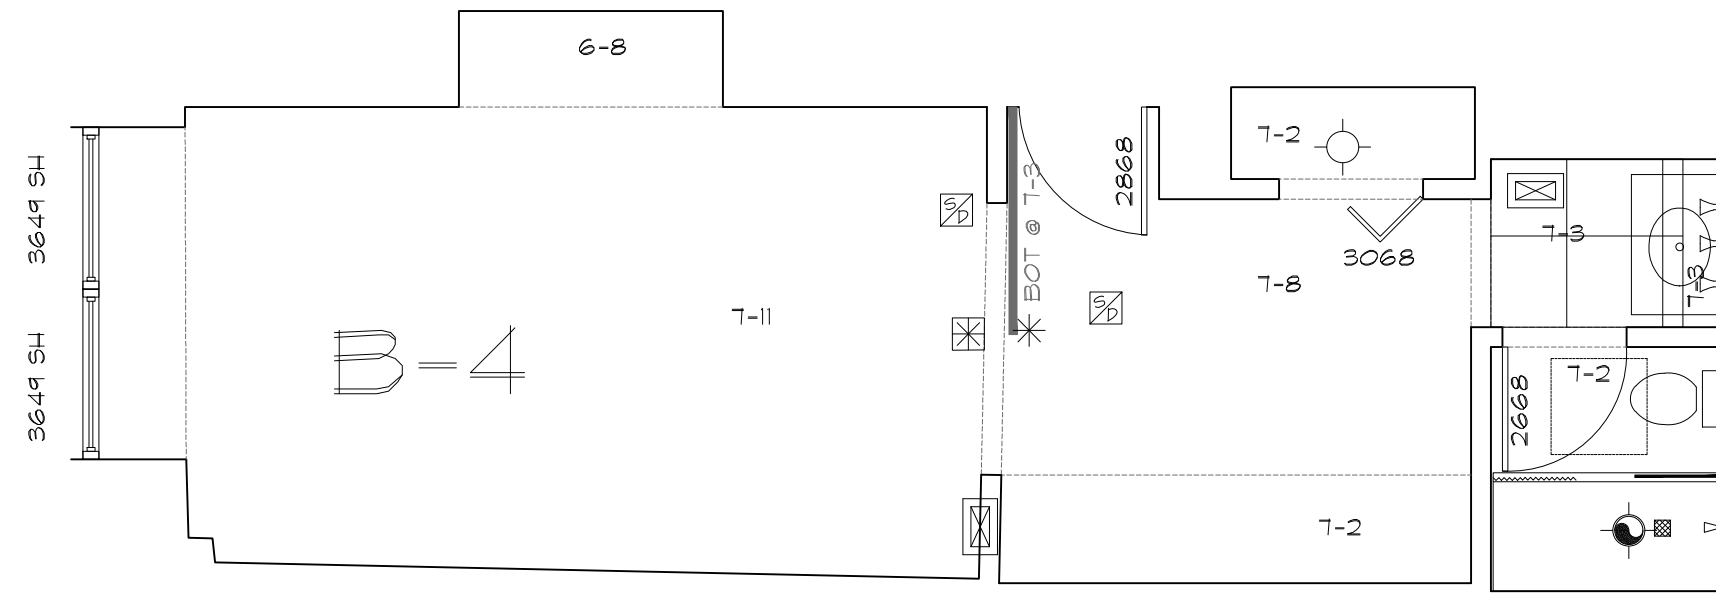

B-4
X15

B-4 - QTY: 11 (315-1415)

ROOM LAYOUTS 1/4"=1'-0"

As BUILT
PROFESSIONALS

A DIVISION OF:

AEC

CONSULTANTS INC


www.aecconsultantsinc.com

844.272.8458


© 2016 AEC CONSULTANTS INC

ARCHITECTURAL AS BUILT
HOTEL INDIGO
CHICAGO, IL 60610


01	100% SUBMISSION	
NO.	ISSUES REVISIONS	DATE
		SHEET TITLE
HL	PROJECT MANAGER	
HL	PROJECT DIRECTOR	
9-2-16-1	PROJECT NUMBER	
AS NOTED	SCALE	
CL	DRAWN BY	
		SHEET NUMBER
ABR-3		

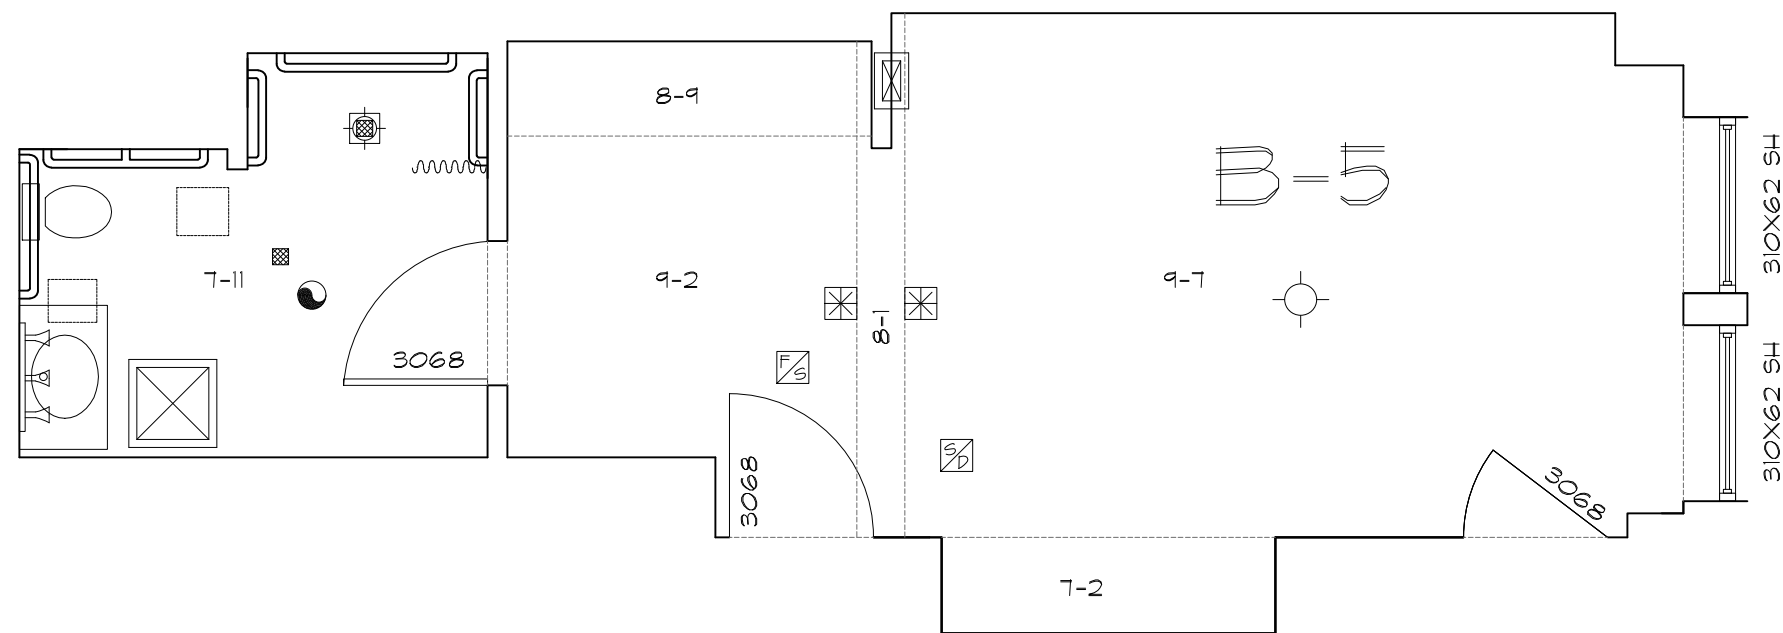


B-5
X01
B-5 ADA - QTY: 1 (201)

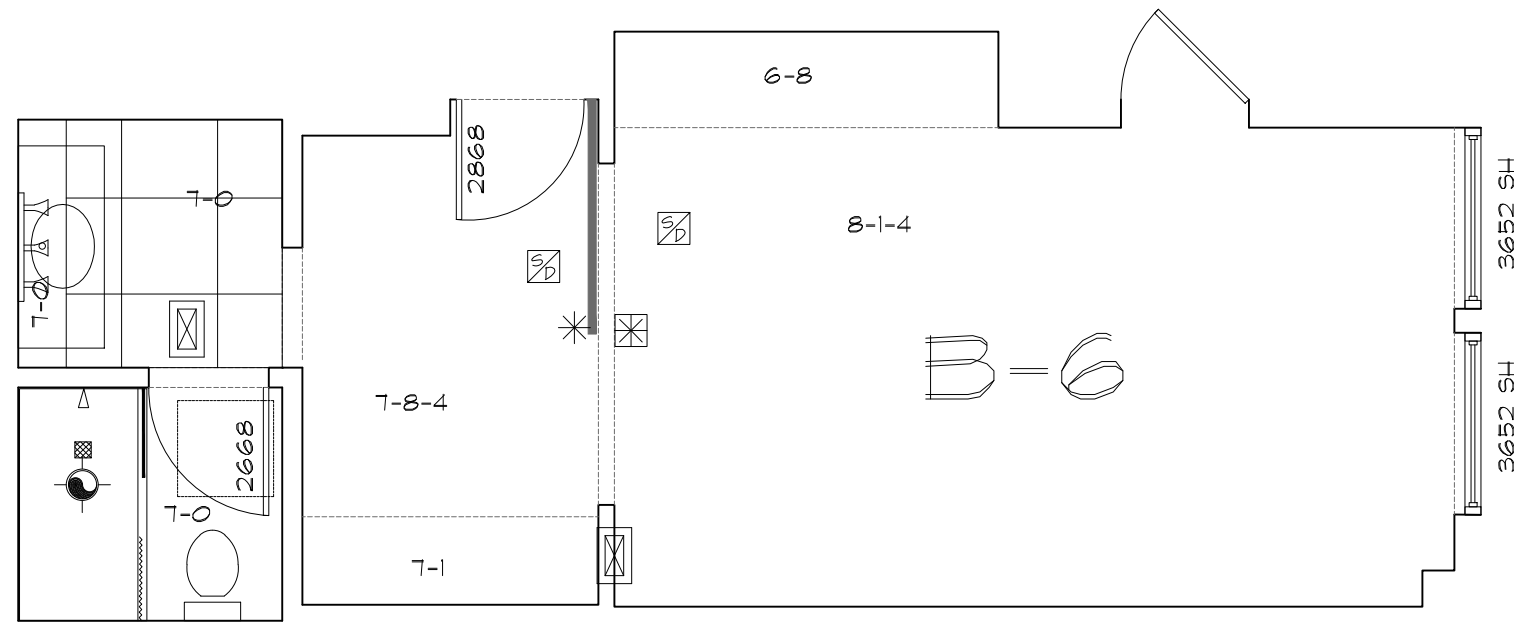


B-6
X03
B-6 - QTY: 2 (1203 & 1403)

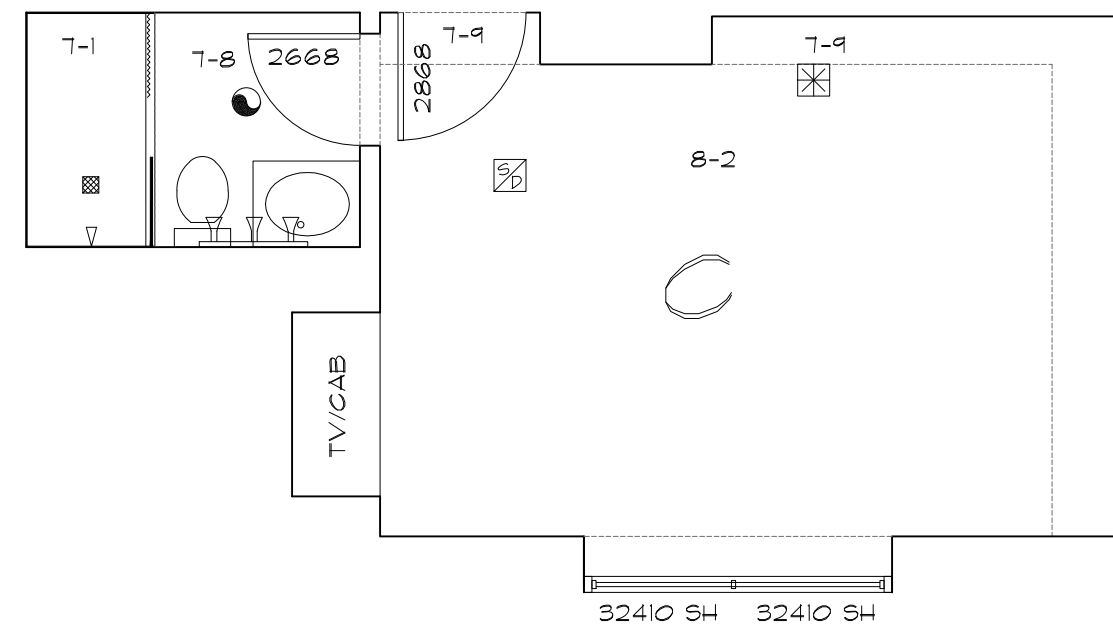


C
X06
C - QTY: 11 (306-1406)

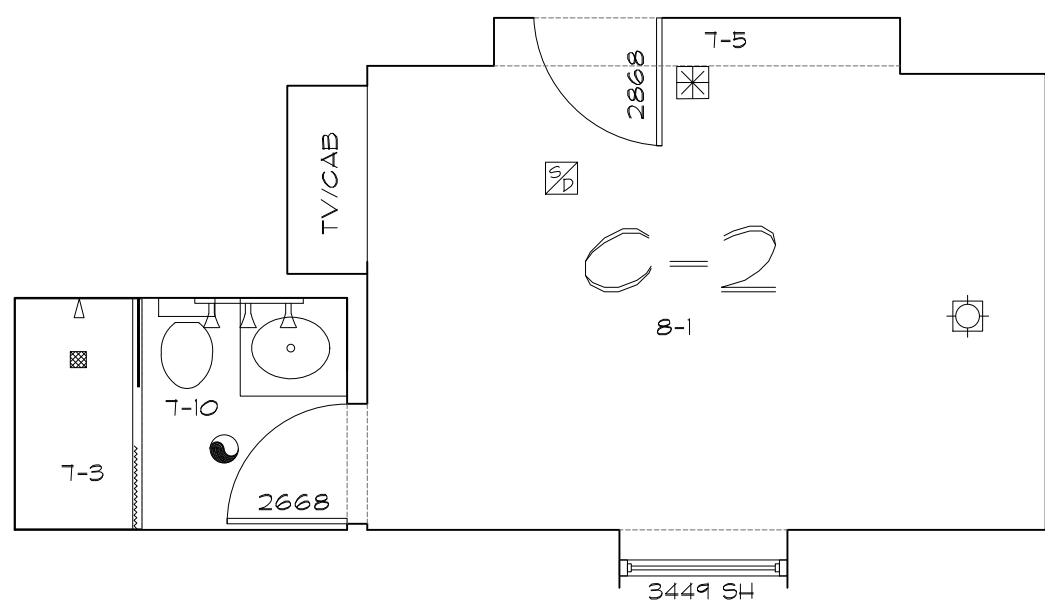

C-2
X10
C-2 - QTY: 11 (310-1410)

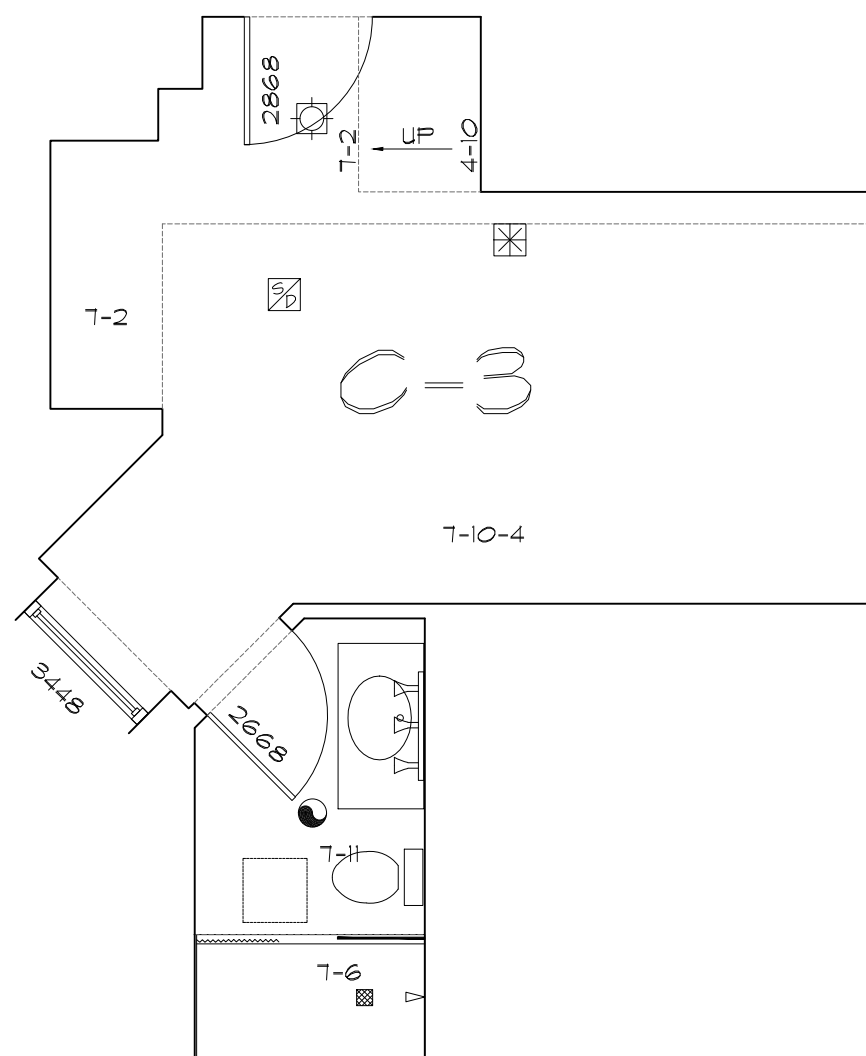

C-3
X04
C-3 - QTY: 1 (1404)

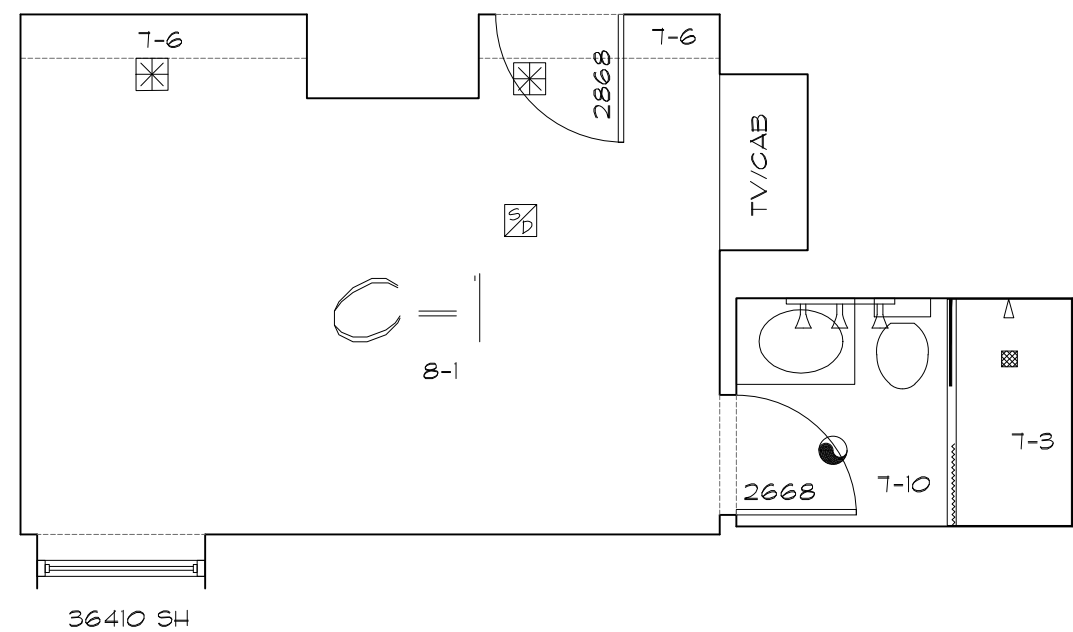

C-1
X08
C-1 - QTY: 11 (308-1408)


ROOM LAYOUTS 1/4"=1'-0"

AS BUILT
PROFESSIONALS
A DIVISION OF:
AEC
CONSULTANTS INC
www.aecconsultantsinc.com
844.272.8458

© 2016 AEC CONSULTANTS INC

ARCHITECTURAL AS BUILT
HOTEL INDIGO
CHICAGO, IL 60610

01	100% SUBMISSION	
NO.	ISSUES REVISIONS	DATE
		SHEET TITLE
HL	PROJECT MANAGER	
HL	PROJECT DIRECTOR	
9-2-16-1	PROJECT NUMBER	
AS NOTED	SCALE	
CL	DRAWN BY	
		SHEET NUMBER

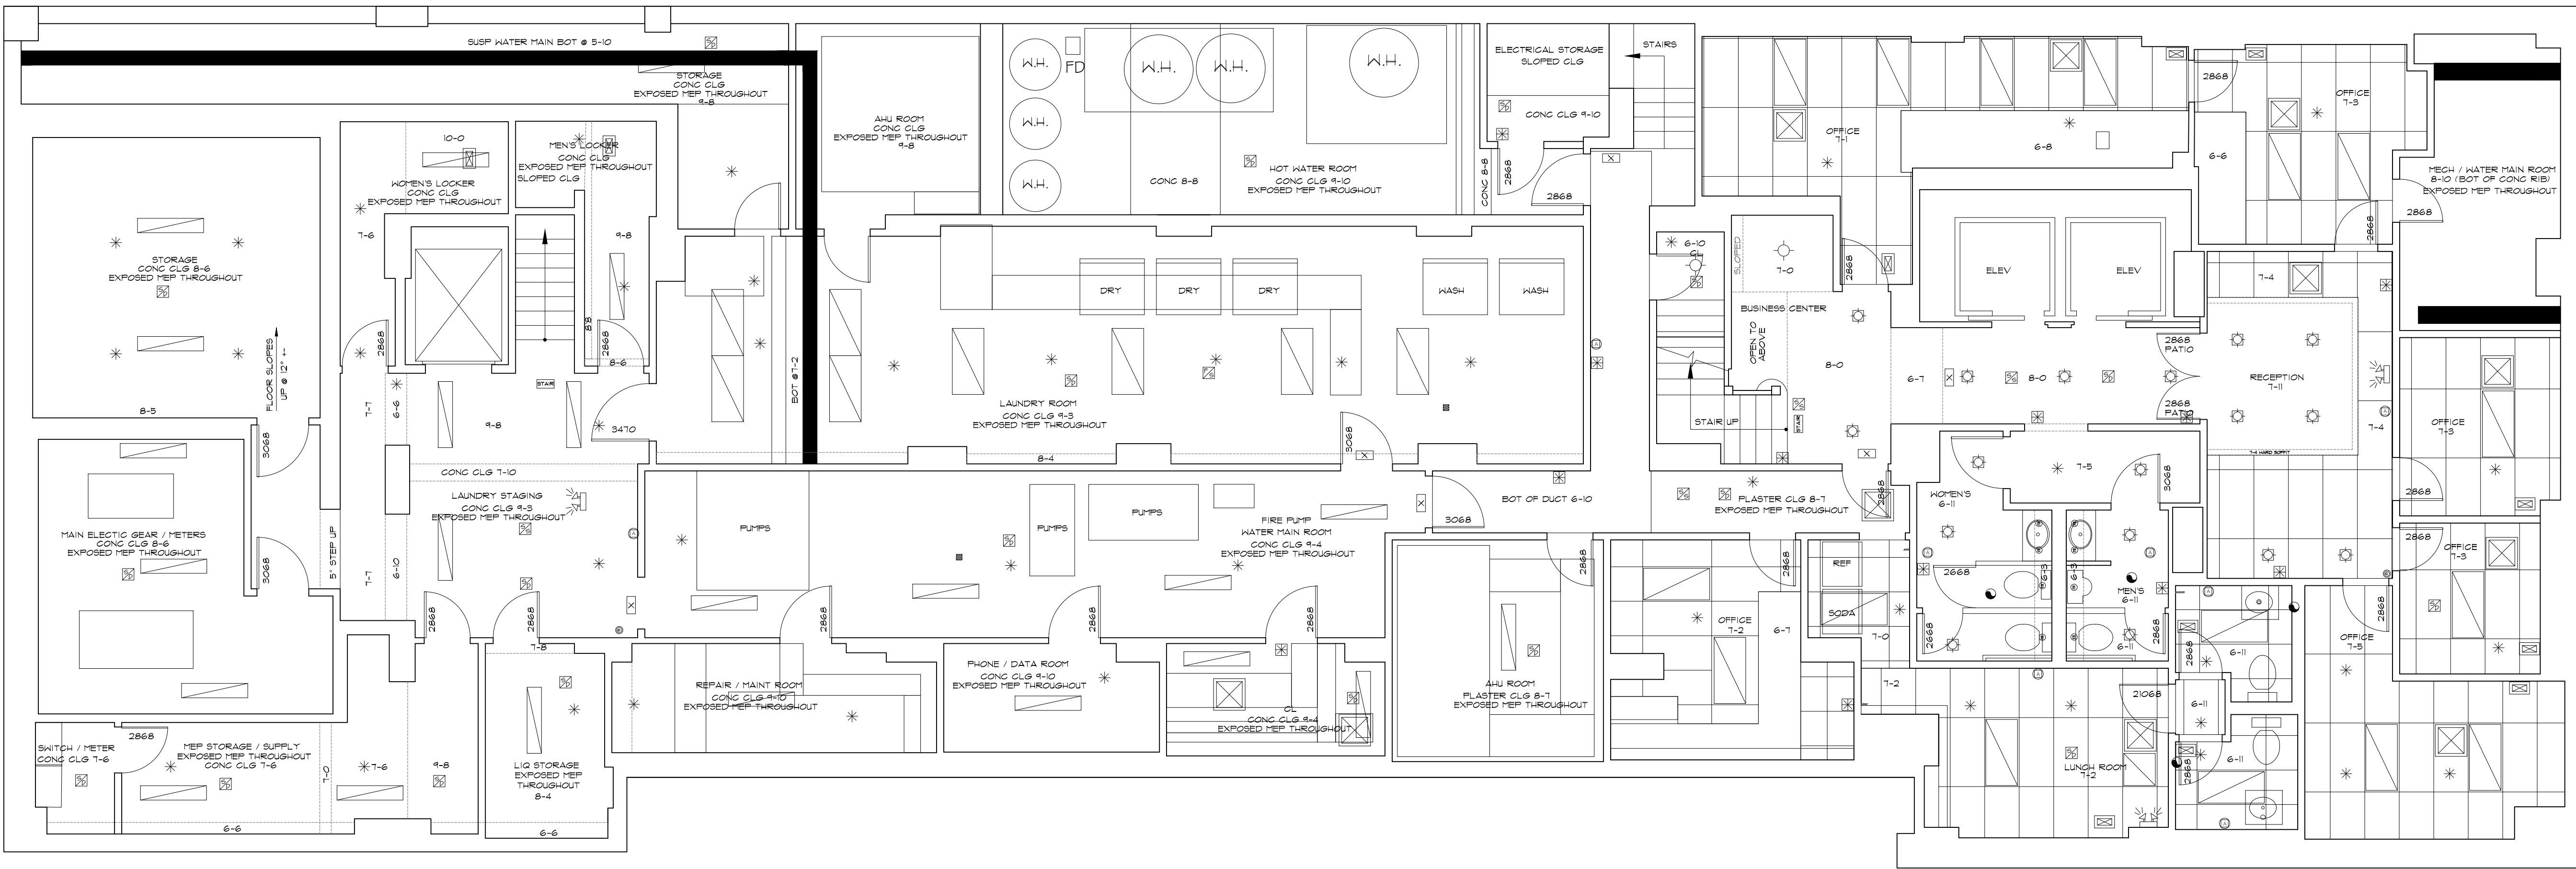

BASEMENT PLAN
3/16"=1'-0"

SYMBOLS LEGEND

RCP

- EXHAUST VENT
- CEILING MOUNTED LIGHT FIXTURE
- CEILING MOUNTED DIRECTIONAL LIGHT
- RECESSED CAN LIGHT
- EYEBALL OR SMALL CAN LIGHT
- PENDANT LIGHT
- INDIVIDUAL FLUOR. LAY-IN FIXTURE 4 BULB
- INDIVIDUAL FLUOR. HANGING FIXTURE 2 BULB
- INDIVIDUAL FLUOR. FLUSH MOUNT FIXTURE 4 BULB
- CAMERA
- MOTION DET.
- SUPPLY VENT
- SUPPLY VENT
- RETURN VENT
- RETURN VENT
- SPEAKER

- TRACK LIGHT OR VANITY LIGHT
- WALL-MOUNTED LIGHT FIXTURE
- EMERGENCY EXIT SIGN
- EMERGENCY EXIT LIGHT
- EMERGENCY EXIT LIGHT W/ SIGN
- LIGHTED STAIR SIGN
- FLOOD LIGHT
- PHOTO CELL
- CEILING FAN
- CEILING FAN W/ LIGHT KIT
- 7-2-6 CEILING HEIGHT AND TRIM 7'-2" ABOVE FLOOR BELOW WITH 6" CROWN MOULDING. NOTE: ALL CEILINGS NOT LABELED ARE PLASTER CEILINGS SHOWN WITH A GRID ARE LAY IN ACOUSTICAL TILE..
- JUNCTION BOX

ELECTRIC

- DATA OUTLET
- TELEPHONE JACK
- ELECTRIC SWITCH
- CABLE TELEVISION OUTLET
- DUPLEX RECEPTACLE OUTLET
- SPECIAL PURPOSE CONNECTION OR OUTLET
- QUADRUPEX RECEPTACLE OUTLET
- FLOOR DUPLEX RECEPTACLE OUTLET
- ELECTRIC PANEL
- ELECTRIC METER
- BUTTON SWITCH
- DISCONNECT SWITCH
- GROUND/FLOOR LIGHT
- KEY PAD

FIRE PROTECTION

- FIRE EXTINGUISHER
- FIRE PULL
- FIRE ALARM (HORN/STROBE)
- SMOKE DETECTOR
- SMOKE ALARM SPEAKER
- SPRINKLER HEAD CEILING MOUNT
- SPRINKLER HEAD WALL MOUNT

MEP

- THERMOSTAT
- FLOOR DRAIN
- VALVE
- HOSE BIB
- WATER SUPPLY
- SUSPENDED GAS HEATER

MISC

- BOLLARD

ARCHITECTURAL AS BUILT HOTEL INDIGO CHICAGO, IL 60610


01 100% SUBMISSION
NO. ISSUES | REVISIONS

DATE

SHEET TITLE

HL	PROJECT MANAGER
HL	PROJECT DIRECTOR
9-2-16-1	PROJECT NUMBER
AS NOTED	SCALE
CL	DRAWN BY
	SHEET NUMBER

AB-1

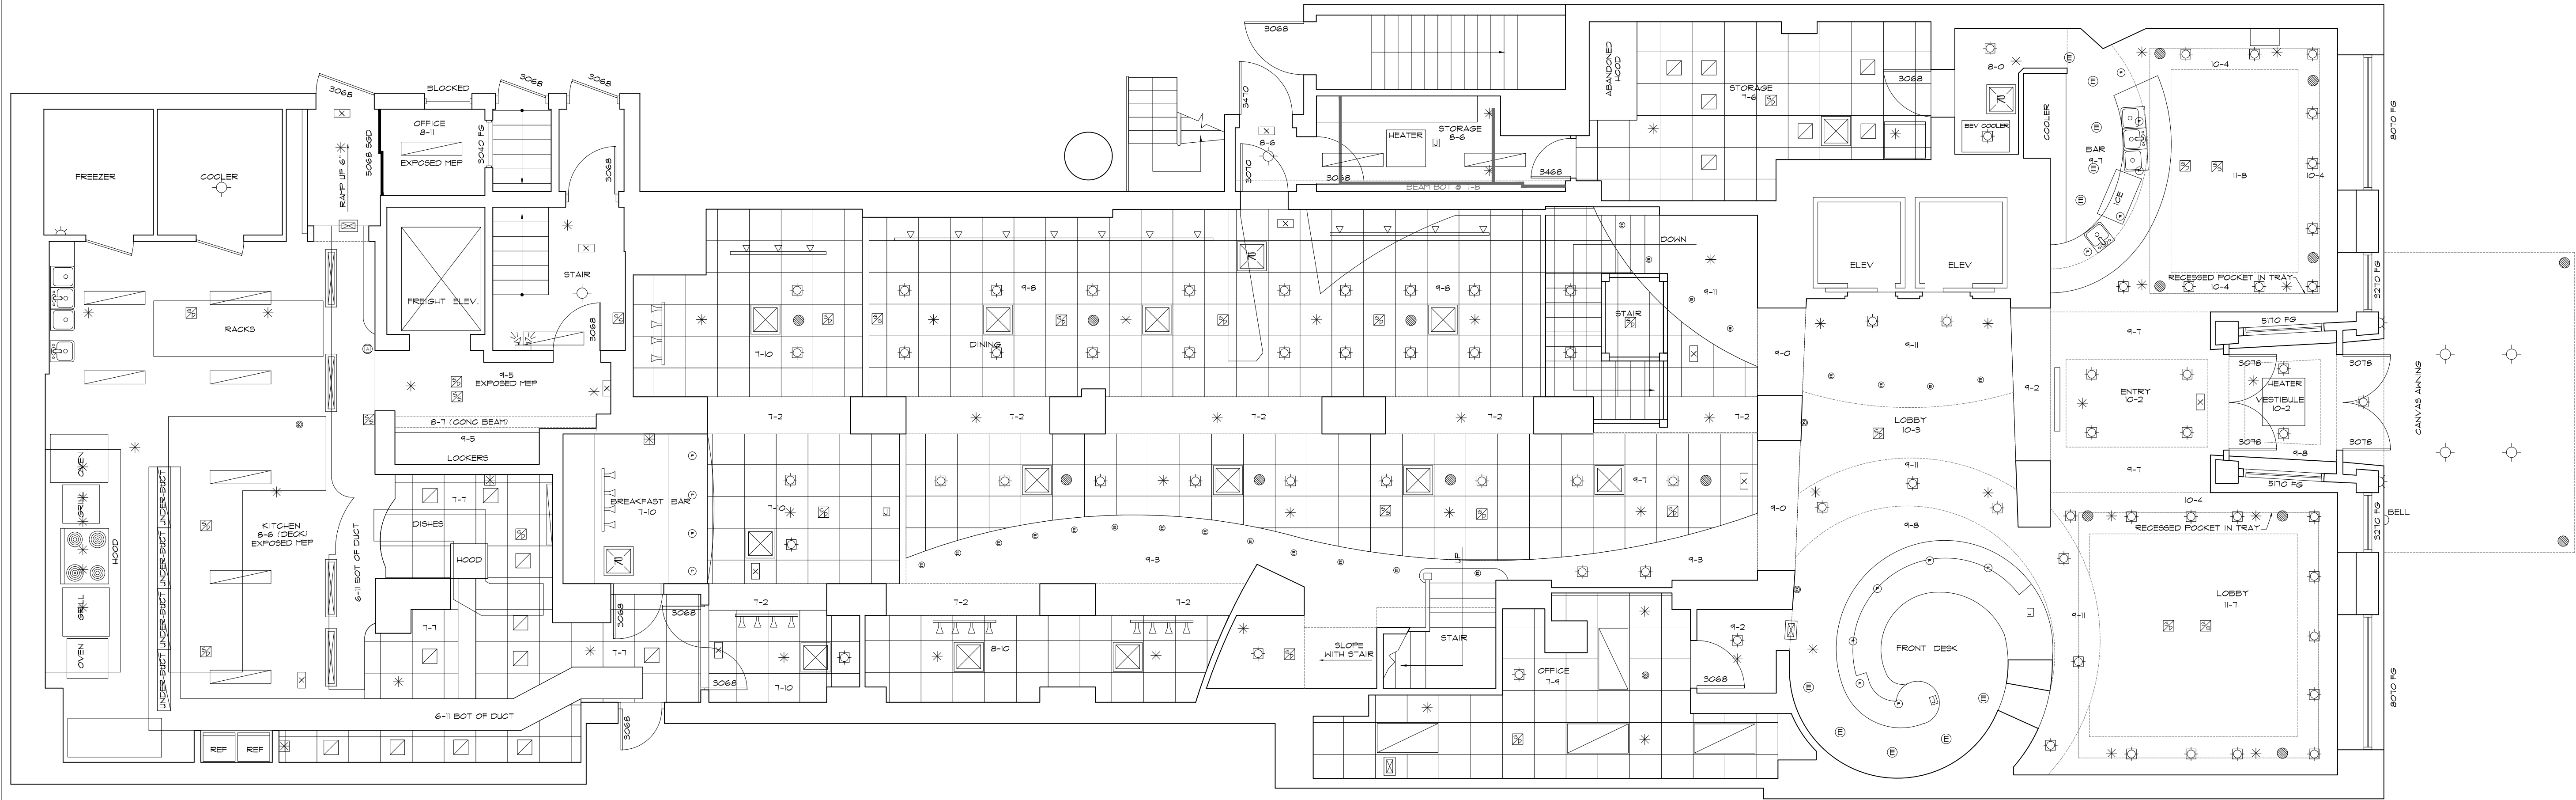

1 GROUND FLOOR PLAN
3/16"=1'-0"

SYMBOLS LEGEND

RCP

	EXHAUST VENT		TRACK LIGHT OR VANITY LIGHT
	CEILING MOUNTED LIGHT FIXTURE		WALL-MOUNTED LIGHT FIXTURE
	CEILING MOUNTED DIRECTIONAL LIGHT		EMERGENCY EXIT SIGN
	RECESSED CAN LIGHT		EMERGENCY EXIT LIGHT
	EYEBALL OR SMALL CAN LIGHT		EMERGENCY EXIT LIGHT W/ SIGN
	PENDANT LIGHT		LIGHTED STAIR SIGN
	INDIVIDUAL FLUOR. LAY-IN FIXTURE 4 BULB		FLOOD LIGHT
	INDIVIDUAL FLUOR. HANGING FIXTURE 2 BULB		PHOTO CELL
	INDIVIDUAL FLUOR. FLUSH MOUNT FIXTURE 4 BULB		CEILING FAN
	CAMERA		CEILING FAN W/ LIGHT KIT
	MOTION DET.		7'-2"-6" CEILING HEIGHT AND TRIM 7'-2" ABOVE FLOOR BELOW WITH 6" CROWN MOULDING. NOTE: ALL CEILINGS NOT LABELED ARE PLASTER CEILINGS SHOWN WITH A GRID ARE LAY IN ACOUSTICAL TILE..
	SUPPLY VENT		JUNCTION BOX
	SUPPLY VENT		
	RETURN VENT		
	RETURN VENT		
	SPEAKER		

ELECTRIC

	DATA OUTLET
	TELEPHONE JACK
	ELECTRIC SWITCH
	CABLE TELEVISION OUTLET
	DUPLEX RECEPTACLE OUTLET
	SPECIAL PURPOSE CONNECTION OR OUTLET
	QUADRUPEX RECEPTACLE OUTLET
	FLOOR DUPLEX RECEPTACLE OUTLET
	ELECTRIC PANEL
	ELECTRIC METER
	BUTTON SWITCH
	DISCONNECT SWITCH
	GROUND/FLOOR LIGHT
	KEY PAD

FIRE PROTECTION

	FIRE EXTINGUISHER
	FIRE PULL
	FIRE ALARM (HORN/SRTOKE)
	SMOKE DETECTOR
	SMOKE ALARM SPEAKER
	SPRINKLER HEAD CEILING MOUNT
	SPRINKLER HEAD WALL MOUNT

MEP

	THERMOSTAT
	FLOOR DRAIN
	VALVE
	HOSE BIB
	WATER SUPPLY
	SUSPENDED GAS HEATER

MISC

	BOLLARD
--	---------


ARCHITECTURAL AS BUILT HOTEL INDIGO CHICAGO, IL 60610

01	100% SUBMISSION
NO.	ISSUES REVISIONS

SHEET TITLE

HL	PROJECT MANAGER
HL	PROJECT DIRECTOR
9-2-16-1	PROJECT NUMBER
AS NOTED	SCALE
CL	DRAWN BY
	SHEET NUMBER

AB-2

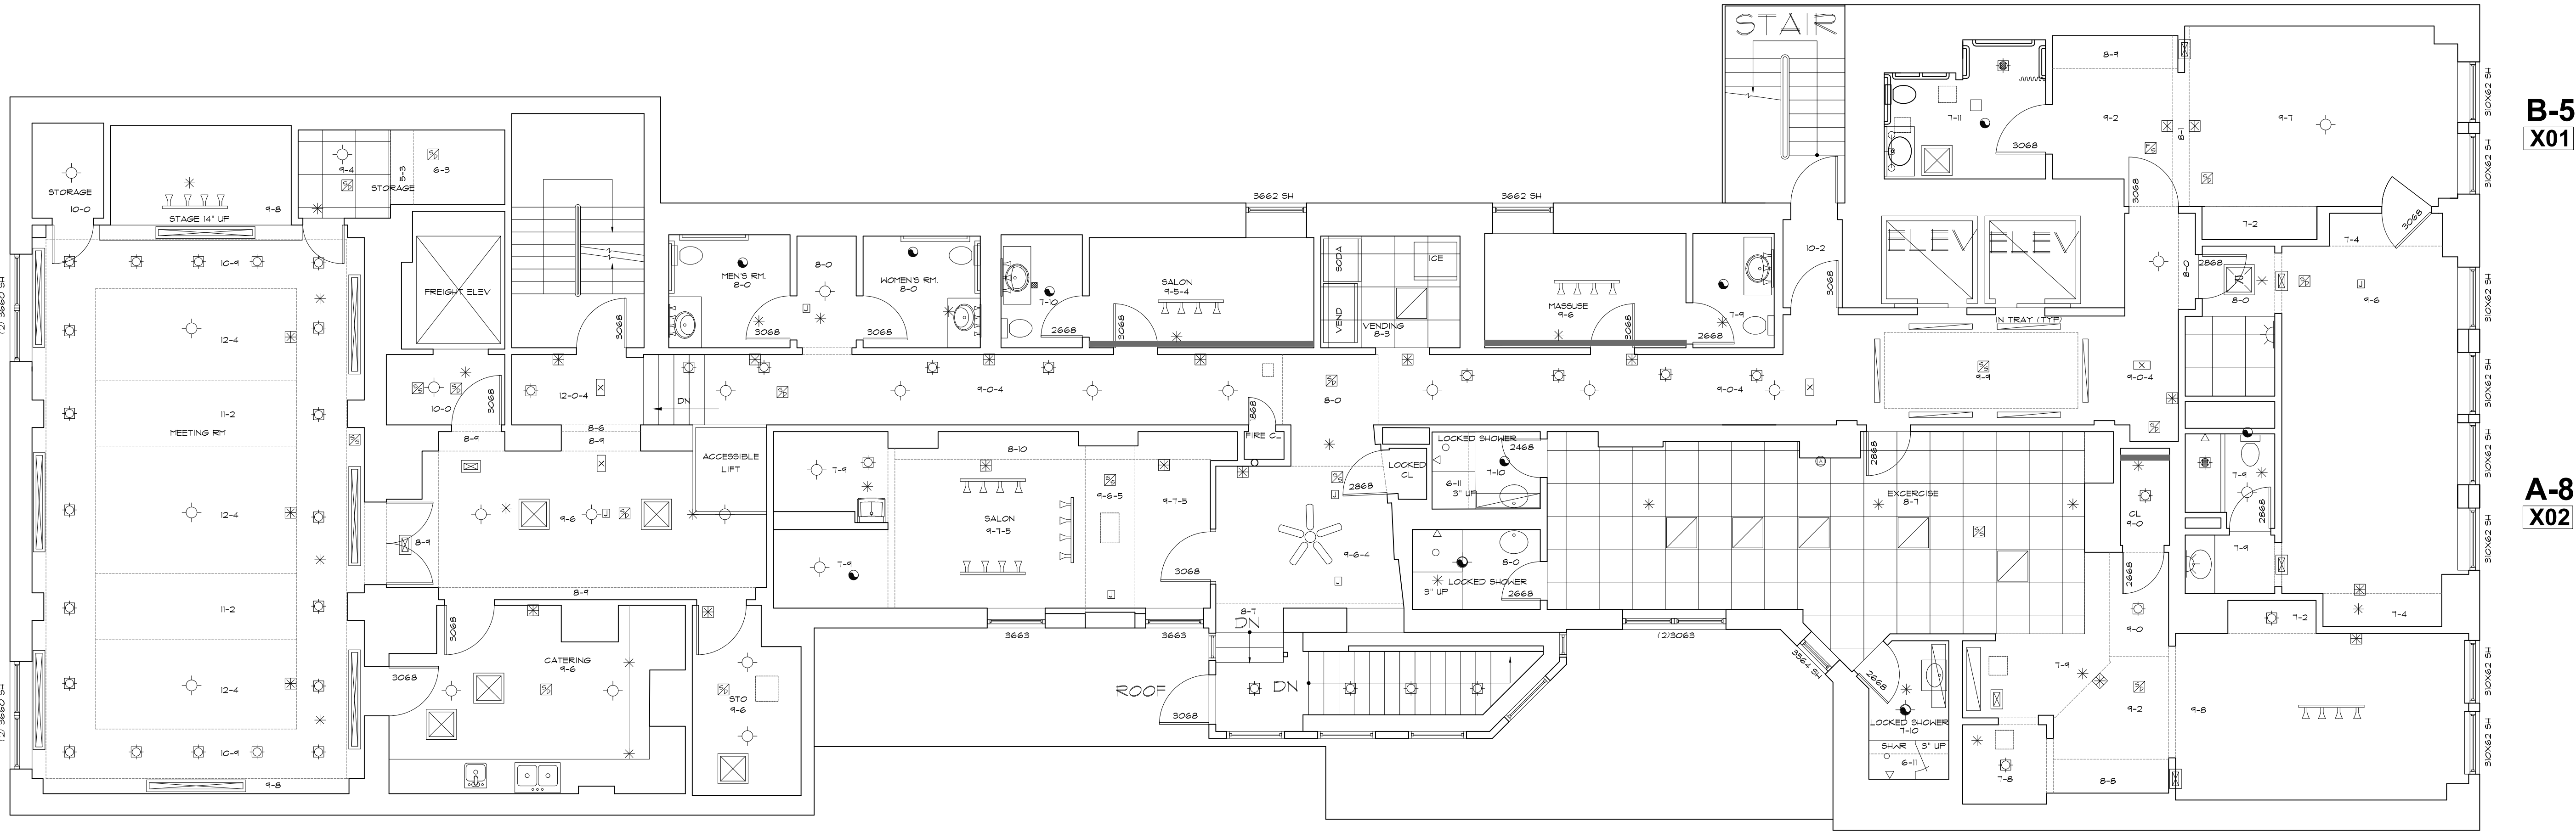

FLOOR 2
3/16"=1'-0"

B-5
X01

A-8
X02

AS BUILT
PROFESSIONALS

A DIVISION OF:

AEC

CONSULTANTS INC

www.aecconsultantsinc.com

844.272.8458

© 2016 AEC CONSULTANTS INC

ARCHITECTURAL AS BUILT

HOTEL INDIGO

CHICAGO, IL 60610


SYMBOLS LEGEND					
RCP			ELECTRIC		FIRE PROTECTION
	EXHAUST VENT		TRACK LIGHT OR VANITY LIGHT		DATA OUTLET
	CEILING MOUNTED LIGHT FIXTURE		WALL-MOUNTED LIGHT FIXTURE		TELEPHONE JACK
	CEILING MOUNTED DIRECTIONAL LIGHT		EMERGENCY EXIT SIGN		ELECTRIC SWITCH
	RECESSED CAN LIGHT		EMERGENCY EXIT LIGHT		CABLE TELEVISION OUTLET
	EYEBALL OR SMALL CAN LIGHT		EMERGENCY EXIT LIGHT W/ SIGN		DUPLEX RECEPTACLE OUTLET
	PENDANT LIGHT		LIGHTED STAIR SIGN		SPECIAL PURPOSE CONNECTION OR OUTLET
	INDIVIDUAL FLUOR. LAY-IN FIXTURE 4 BULB		FLOOD LIGHT		QUADRUPEX RECEPTACLE OUTLET
	INDIVIDUAL FLUOR. HANGING FIXTURE 2 BULB		PHOTO CELL		FLOOR DUPLEX RECEPTACLE OUTLET
	INDIVIDUAL FLUOR. FLUSH MOUNT FIXTURE 4 BULB		CEILING FAN		ELECTRIC PANEL
	CAMERA		CEILING FAN W/ LIGHT KIT		ELECTRIC METER
	MOTION DET.		7-2-6 CEILING HEIGHT AND TRIM 7'-2" ABOVE FLOOR BELOW WITH 6" CROWN MOULDING. NOTE: ALL CEILINGS NOT LABELED ARE PLASTER CEILINGS SHOWN WITH A GRID ARE LAY IN ACOUSTICAL TILE..		BUTTON SWITCH
	SUPPLY VENT		JUNCTION BOX		DISCONNECT SWITCH
	SUPPLY VENT				GROUND/FLOOR LIGHT
	RETURN VENT				KEY PAD
	RETURN VENT				
	SPEAKER				

MEP	
	THERMOSTAT
	FLOOR DRAIN
	VALVE
	HOSE BIB
	WATER SUPPLY
	SUSPENDED GAS HEATER

MISC	
	BOLLARD

01	100% SUBMISSION	
NO.	ISSUES REVISIONS	DATE
SHEET TITLE		
HL	PROJECT MANAGER	
HL	PROJECT DIRECTOR	
9-2-16-1	PROJECT NUMBER	
AS NOTED	SCALE	
CL	DRAWN BY	
	SHEET NUMBER	

AB-3

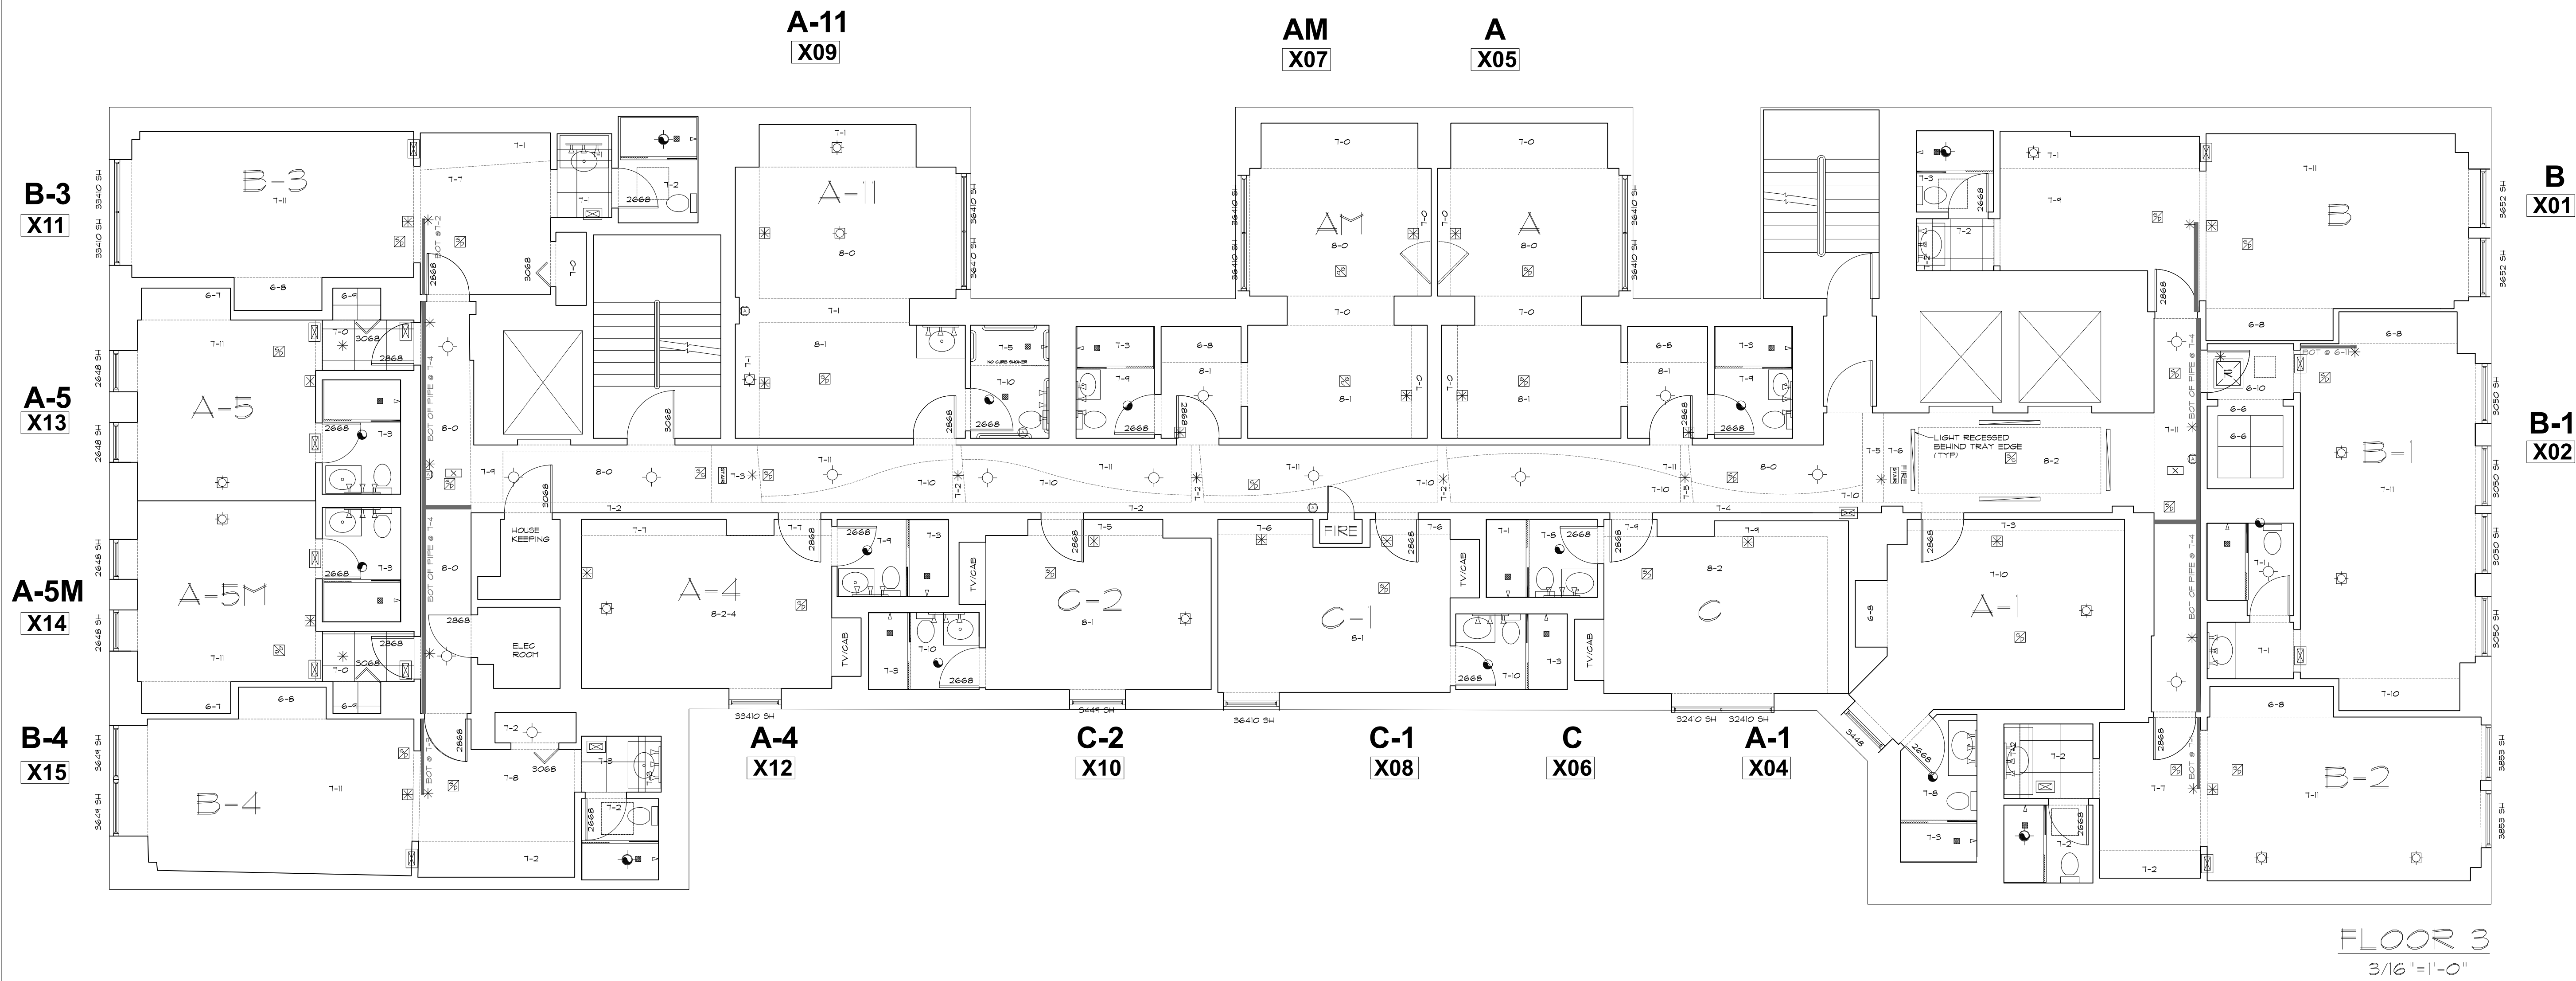

SYMBOLS LEGEND					
RCP			ELECTRIC		FIRE PROTECTION
	EXHAUST VENT			FIRE EXTINGUISHER	
	CEILING MOUNTED LIGHT FIXTURE			FIRE PULL	
	CEILING MOUNTED DIRECTIONAL LIGHT			FIRE ALARM (HORN/SRTO)	
	RECESSED CAN LIGHT			SMOKE DETECTOR	
	EYEBALL OR SMALL CAN LIGHT			SMOKE ALARM SPEAKER	
	PENDANT LIGHT			SPRINKLER HEAD CEILING MOUNT	
	INDIVIDUAL FLUOR. LAY-IN FIXTURE 4 BULB			SPRINKLER HEAD WALL MOUNT	
	INDIVIDUAL FLUOR. HANGING FIXTURE 2 BULB			MEP	
	INDIVIDUAL FLUOR. FLUSH MOUNT FIXTURE 4 BULB			THERMOSTAT	
	CAMERA			FLOOR DRAIN	
	MOTION DET.			VALVE	
	SUPPLY VENT	7-2-6 CEILING HEIGHT AND TRIM 7'-2" ABOVE FLOOR BELOW WITH 6" CROWN MOULDING. NOTE: ALL CEILINGS NOT LABELED ARE PLASTER CEILINGS SHOWN WITH A GRID ARE LAY IN ACOUSTICAL TILE..		HOSE BIB	
	RETURN VENT			WATER SUPPLY	
	RETURN VENT			SUSPENDED GAS HEATER	
	SPEAKER			MISC	
				BOLLARD	

AS BUILT
PROFESSIONALS

A DIVISION OF:

AEC
CONSULTANTS INC

www.aecconsultantsinc.com

844.272.8458


© 2016 AEC CONSULTANTS INC

ARCHITECTURAL AS BUILT
HOTEL INDIGO

CHICAGO, IL 60610







01	100% SUBMISSION	
NO.	ISSUES REVISIONS	DATE
SHEET TITLE		
HL	PROJECT MANAGER	
HL	PROJECT DIRECTOR	
9-2-16-1	PROJECT NUMBER	
AS NOTED	SCALE	
CL	DRAWN BY	
SHEET NUMBER		

AB-4

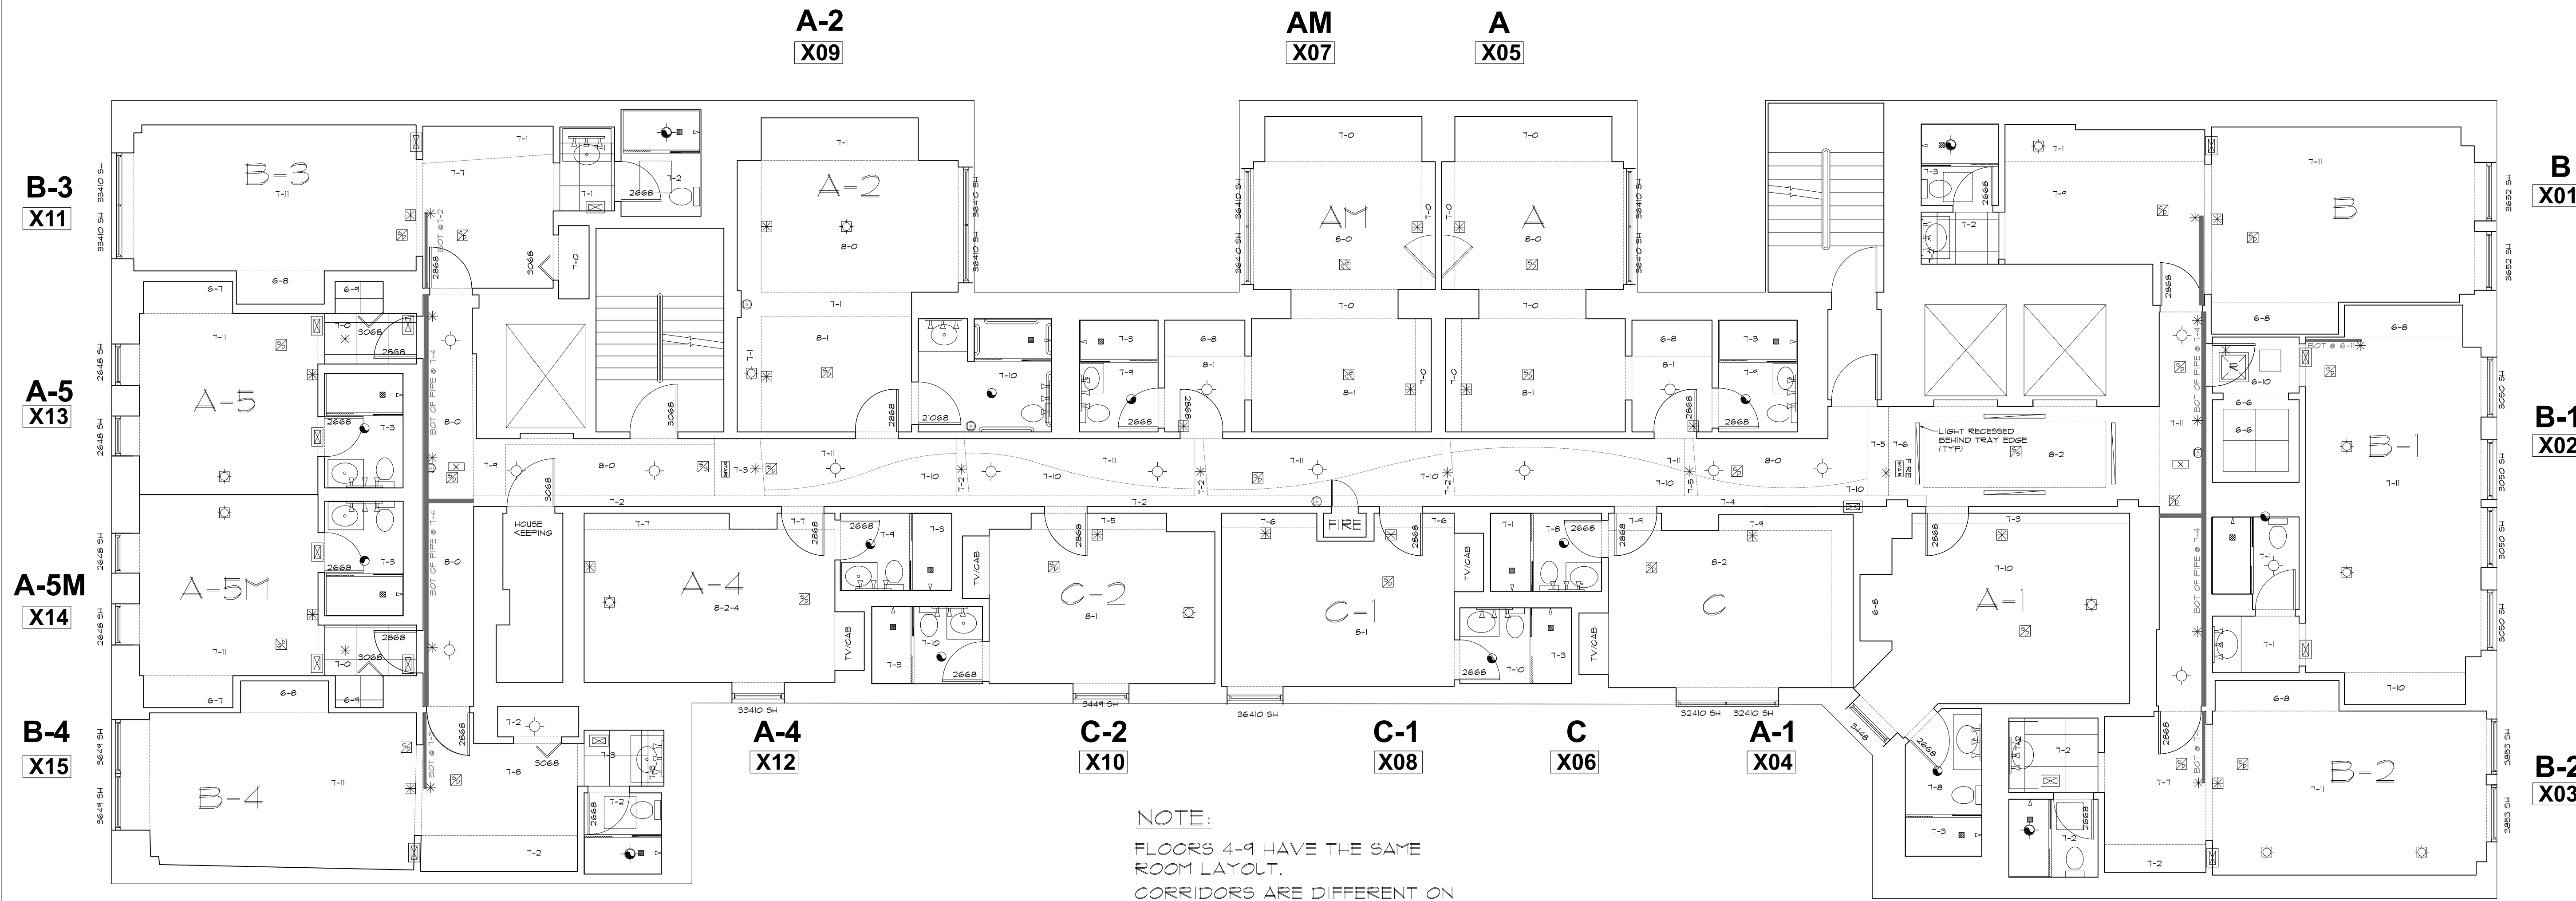

FLOOR 4
3/16"=1'-0"

      SYMBOLS LEGEND

RCP		ELECTRIC		FIRE PROTECTION			
	EXHAUST VENT		TRACK LIGHT OR VANITY LIGHT		DATA OUTLET		FIRE EXTINGUISHER
	CEILING MOUNTED LIGHT FIXTURE		WALL-MOUNTED LIGHT FIXTURE		TELEPHONE JACK		FIRE PULL
	CEILING MOUNTED DIRECTIONAL LIGHT		EMERGENCY EXIT SIGN		ELECTRIC SWITCH		FIRE ALARM (HORN/SRTOEB)
	RECESSED CAN LIGHT		EMERGENCY EXIT LIGHT		CABLE TELEVISION OUTLET		SMOKE DETECTOR
	EYEBALL OR SMALL CAN LIGHT		EMERGENCY EXIT LIGHT W/ SIGN		DUPLEX RECEPTACLE OUTLET		SMOKE ALARM SPEAKER
	PENDANT LIGHT		LIGHTED STAIR SIGN		SPECIAL PURPOSE CONNECTION OR OUTLET		SPRINKLER HEAD CEILING MOUNT
	INDIVIDUAL FLUOR. LAY-IN FIXTURE 4 BULB		FLOOD LIGHT		QUADRUPEX RECEPTACLE OUTLET		SPRINKLER HEAD WALL MOUNT
	INDIVIDUAL FLUOR. HANGING FIXTURE 2 BULB		PHOTO CELL		FLOOR DUPLEX RECEPTACLE OUTLET		
	INDIVIDUAL FLUOR. FLUSH MOUNT FIXTURE 4 BULB		CEILING FAN		ELECTRIC PANEL		THERMOSTAT
	CAMERA		CEILING FAN W/ LIGHT KIT		ELECTRIC METER		FLOOR DRAIN
	MOTION DET.				BUTTON SWITCH		VALVE
	SUPPLY VENT	7-2-6	CEILING HEIGHT AND TRIM 7'-2" ABOVE FLOOR BELOW WITH 6" CROWN MOULDING. NOTE: ALL CEILINGS NOT LABELED ARE PLASTER. CEILINGS SHOWN WITH A GRID ARE LAY IN ACOUSTICAL TILE.		DISCONNECT SWITCH		HOSE BIB
	SUPPLY VENT		JUNCTION BOX		GROUND/FLOOR LIGHT		WATER SUPPLY
	RETURN VENT				KEY PAD		SUSPENDED GAS HEATER
	RETURN VENT						
	SPEAKER						

MEP		FIRE PROTECTION	


AS BUILT
PROFESSIONALS
A DIVISION OF:

AEC
CONSULTANTS INC
www.aecconsultantsinc.com
844.272.8458

© 2016 AEC CONSULTANTS INC

ARCHITECTURAL AS BUILT HOTEL INDIGO CHICAGO, IL 60610

01	100% SUBMISSION	
NO.	ISSUES REVISIONS	DATE
SHEET TITLE		
HL	PROJECT MANAGER	
HL	PROJECT DIRECTOR	
9-2-16-1	PROJECT NUMBER	
AS NOTED	SCALE	
CL	DRAWN BY	
SHEET NUMBER		

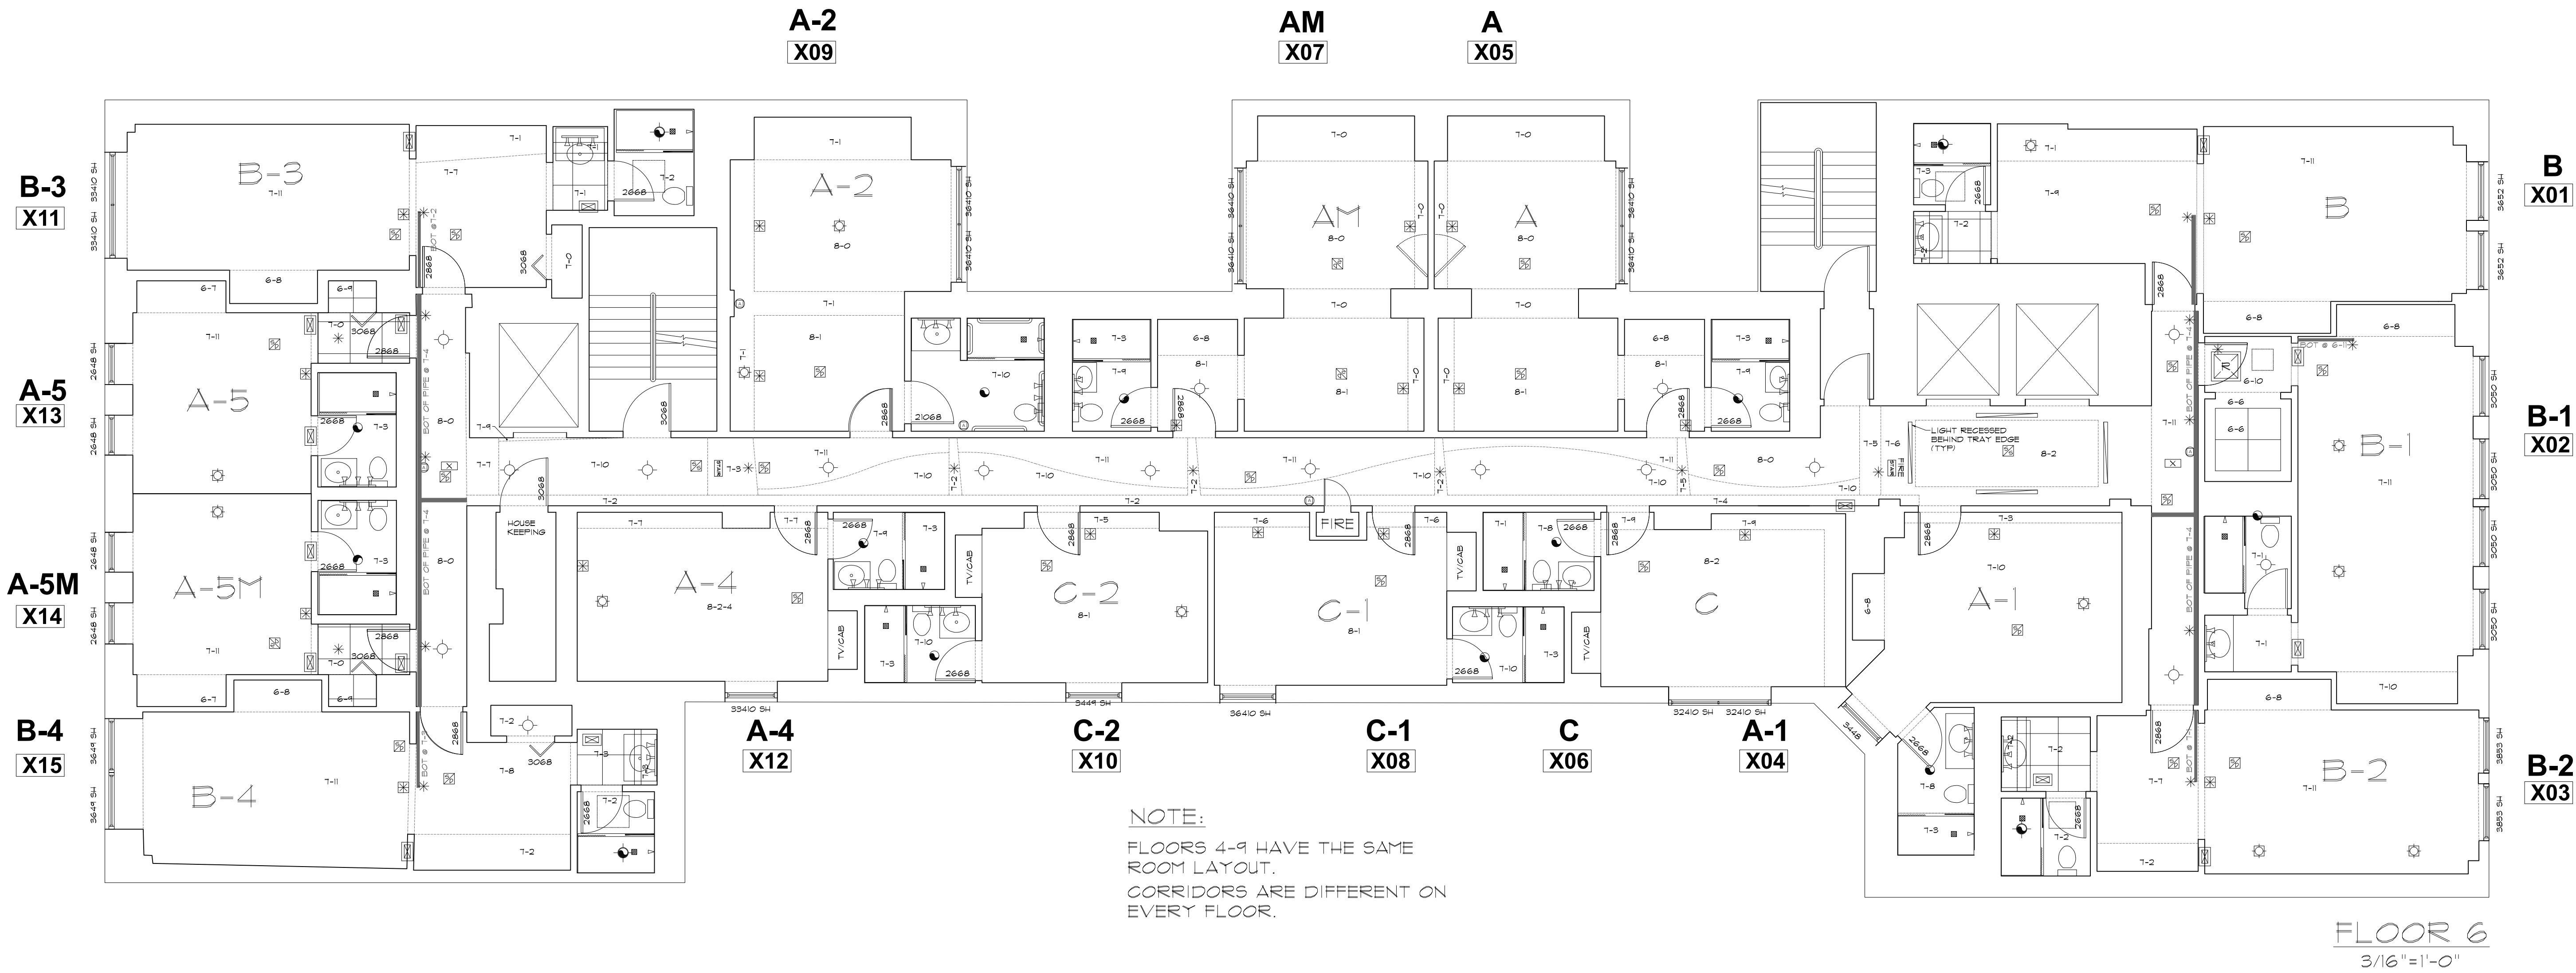

SYMBOLS LEGEND

RCP		ELECTRIC		FIRE PROTECTION	
	EXHAUST VENT		TRACK LIGHT OR VANITY LIGHT		FIRE EXTINGUISHER
	CEILING MOUNTED LIGHT FIXTURE		WALL-MOUNTED LIGHT FIXTURE		FIRE PULL
	CEILING MOUNTED DIRECTIONAL LIGHT		EMERGENCY EXIT SIGN		FIRE ALARM (HORN/SRTO)
	RECESSED CAN LIGHT		EMERGENCY EXIT LIGHT		SMOKE DETECTOR
	EYEBALL OR SMALL CAN LIGHT		EMERGENCY EXIT LIGHT W/ SIGN		SMOKE ALARM SPEAKER
	PENDANT LIGHT		LIGHTED STAIR SIGN		SPRINKLER HEAD CEILING MOUNT
	INDIVIDUAL FLUOR. LAY-IN FIXTURE 4 BULB		FLOOD LIGHT		SPRINKLER HEAD WALL MOUNT
	INDIVIDUAL FLUOR. HANGING FIXTURE 2 BULB		PHOTO CELL		
	INDIVIDUAL FLUOR. FLUSH MOUNT FIXTURE 4 BULB		CEILING FAN		
	CAMERA		CEILING FAN W/ LIGHT KIT		
	MOTION DET.		CEILING HEIGHT AND TRIM 7'-2" ABOVE FLOOR BELOW WITH 6" CROWN MOULDING. NOTE: ALL CEILINGS NOT LABELED ARE PLASTER CEILINGS SHOWN WITH A GRID ARE LAY IN ACOUSTICAL TILE..		
	SUPPLY VENT		JUNCTION BOX		
	SUPPLY VENT				
	RETURN VENT				
	RETURN VENT				
	SPEAKER				

MEP	
	THERMOSTAT
	FLOOR DRAIN
	VALVE
	HOSE BIB
	WATER SUPPLY
	SUSPENDED GAS HEATER

MISC	
	BOLLARD

AS BUILT
PROFESSIONALS

A DIVISION OF:

AEC
CONSULTANTS INC

www.aecconsultantsinc.com


844.272.8458

© 2016 AEC CONSULTANTS INC

ARCHITECTURAL AS BUILT
HOTEL INDIGO
CHICAGO, IL 60610

01	100% SUBMISSION	
NO.	ISSUES REVISIONS	DATE
SHEET TITLE		
HL	PROJECT MANAGER	
HL	PROJECT DIRECTOR	
9-2-16-1	PROJECT NUMBER	
AS NOTED	SCALE	
CL	DRAWN BY	
SHEET NUMBER		

AB-7

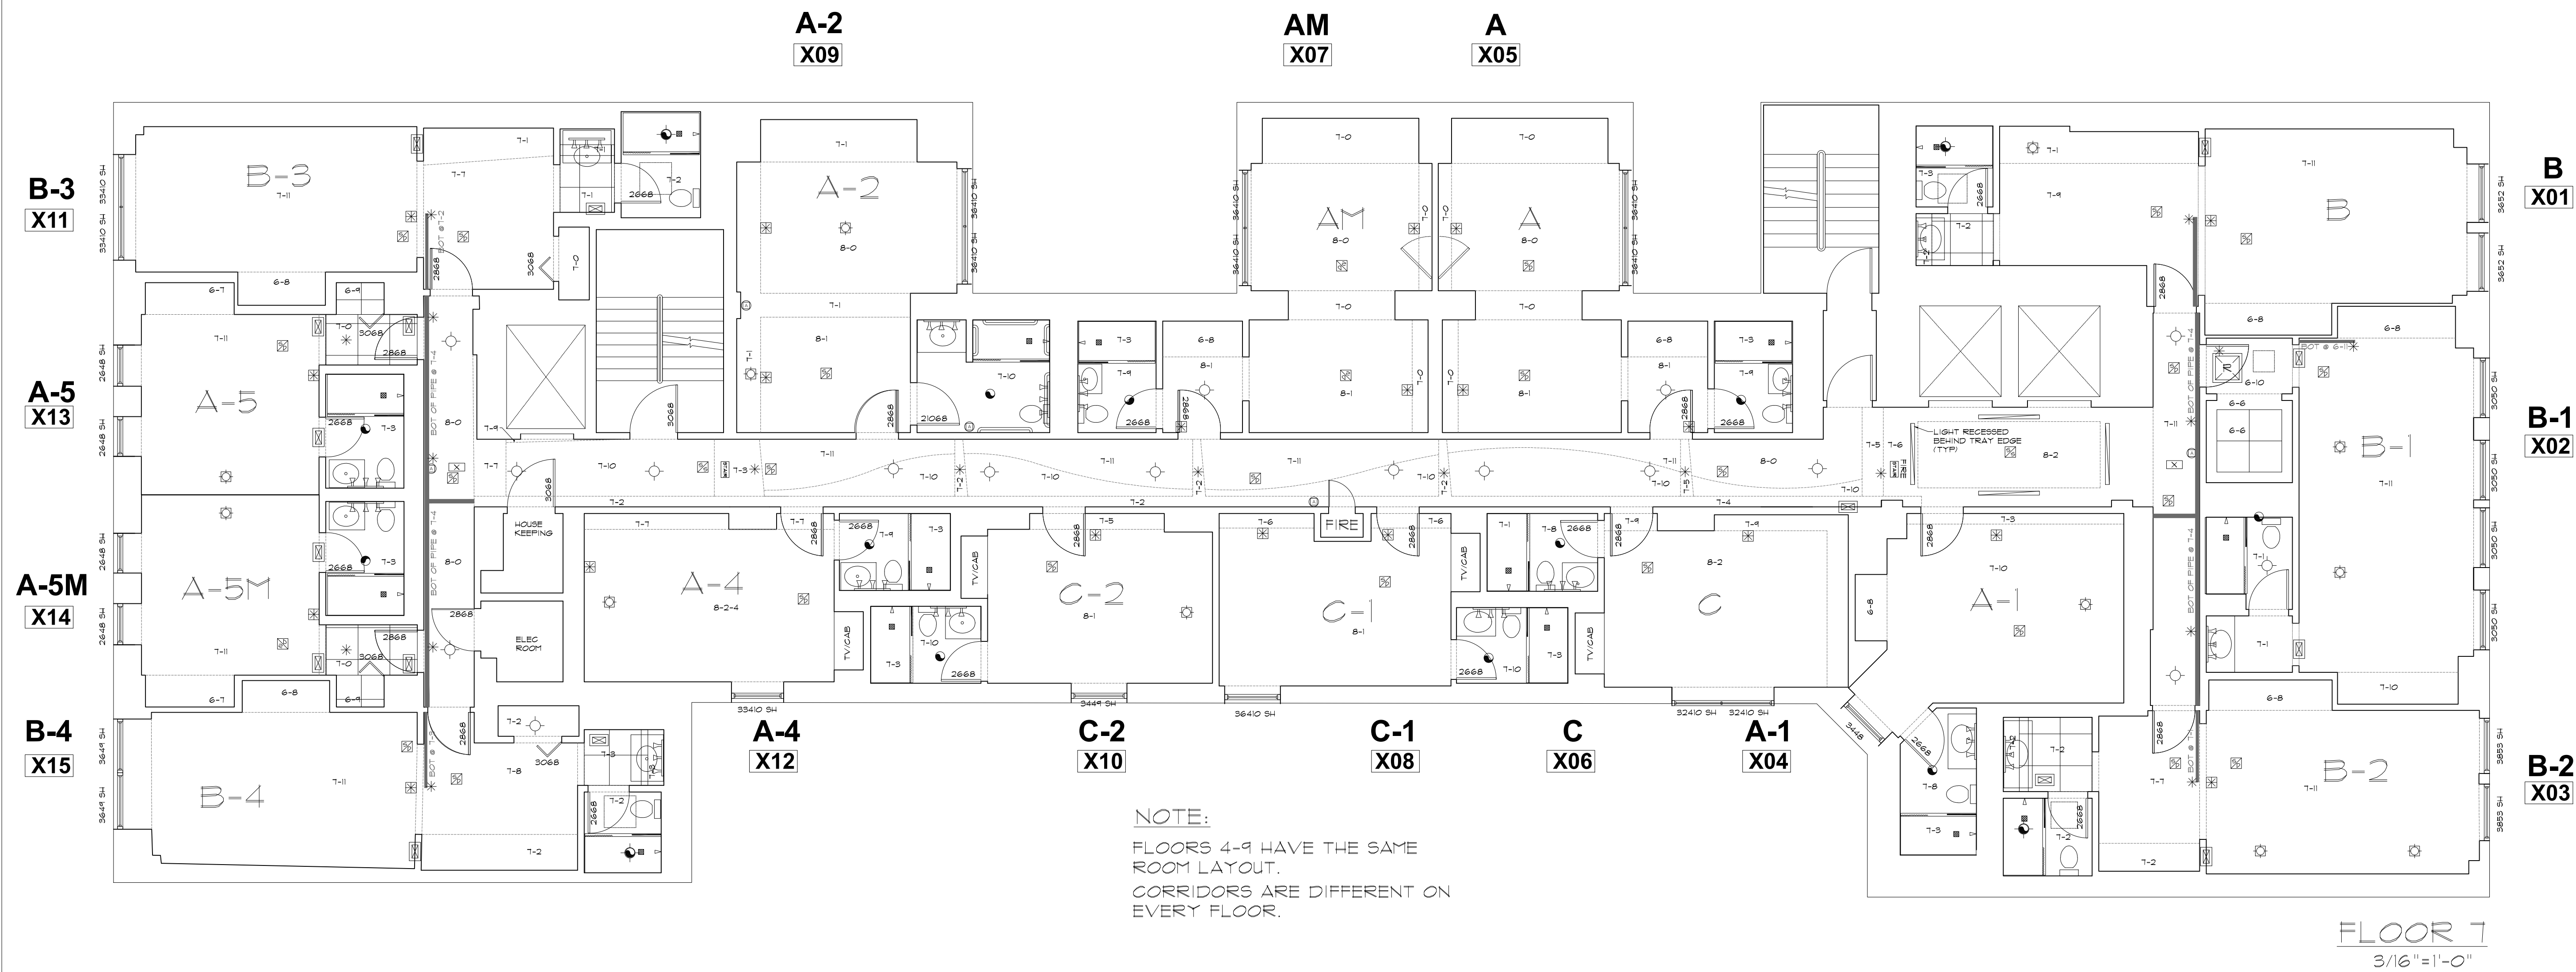

SYMBOLS LEGEND			
RCP		ELECTRIC	
	EXHAUST VENT		DATA OUTLET
	CEILING MOUNTED LIGHT FIXTURE		TELEPHONE JACK
	CEILING MOUNTED DIRECTIONAL LIGHT		ELECTRIC SWITCH
	RECESSED CAN LIGHT		CABLE TELEVISION OUTLET
	EYEBALL OR SMALL CAN LIGHT		DUPLEX RECEPTACLE OUTLET
	PENDANT LIGHT		SPECIAL PURPOSE CONNECTION OR OUTLET
	INDIVIDUAL FLUOR. LAY-IN FIXTURE 4 BULB		QUADRUPEX RECEPTACLE OUTLET
	INDIVIDUAL FLUOR. HANGING FIXTURE 2 BULB		FLOOR DUPLEX RECEPTACLE OUTLET
	INDIVIDUAL FLUOR. FLUSH MOUNT FIXTURE 4 BULB		ELECTRIC PANEL
	CAMERA		ELECTRIC METER
	MOTION DET.		BUTTON SWITCH
	SUPPLY VENT		DISCONNECT SWITCH
	RETURN VENT		GROUND/FLOOR LIGHT
	SPEAKER		KEY PAD
	TRACK LIGHT OR VANITY LIGHT		
	WALL-MOUNTED LIGHT FIXTURE		
	EMERGENCY EXIT SIGN		
	EMERGENCY EXIT LIGHT		
	EMERGENCY EXIT LIGHT W/ SIGN		
	LIGHTED STAIR SIGN		
	FLOOD LIGHT		
	PHOTO CELL		
	CEILING FAN		
	CEILING FAN W/ LIGHT KIT		
	7-2'-6" CEILING HEIGHT AND TRIM 7'-2" ABOVE FLOOR BELOW WITH 6" CROWN MOULDING. NOTE: ALL CEILINGS NOT LABELED ARE PLASTER CEILINGS SHOWN WITH A GRID ARE LAY IN ACOUSTICAL TILE..		
	JUNCTION BOX		

FIRE PROTECTION	
	FIRE EXTINGUISHER
	FIRE PULL
	FIRE ALARM (HORN/SRTOKE)
	SMOKE DETECTOR
	SMOKE ALARM SPEAKER
	SPRINKLER HEAD CEILING MOUNT
	SPRINKLER HEAD WALL MOUNT

MEP	
	THERMOSTAT
	FLOOR DRAIN
	VALVE
	HOSE BIB
	WATER SUPPLY
	SUSPENDED GAS HEATER

MISC	
	BOLLARD

As BUILT PROFESSIONALS

A DIVISION OF:

AEC CONSULTANTS INC

www.aecconsultantsinc.com

844.272.8458

© 2016 AEC CONSULTANTS INC


ARCHITECTURAL AS BUILT

HOTEL INDIGO

CHICAGO, IL 60610

01	100% SUBMISSION	
NO.	ISSUES REVISIONS	DATE
SHEET TITLE		
HL	PROJECT MANAGER	
HL	PROJECT DIRECTOR	
9-2-16-1	PROJECT NUMBER	
AS NOTED	SCALE	
CL	DRAWN BY	
SHEET NUMBER		

AB-8

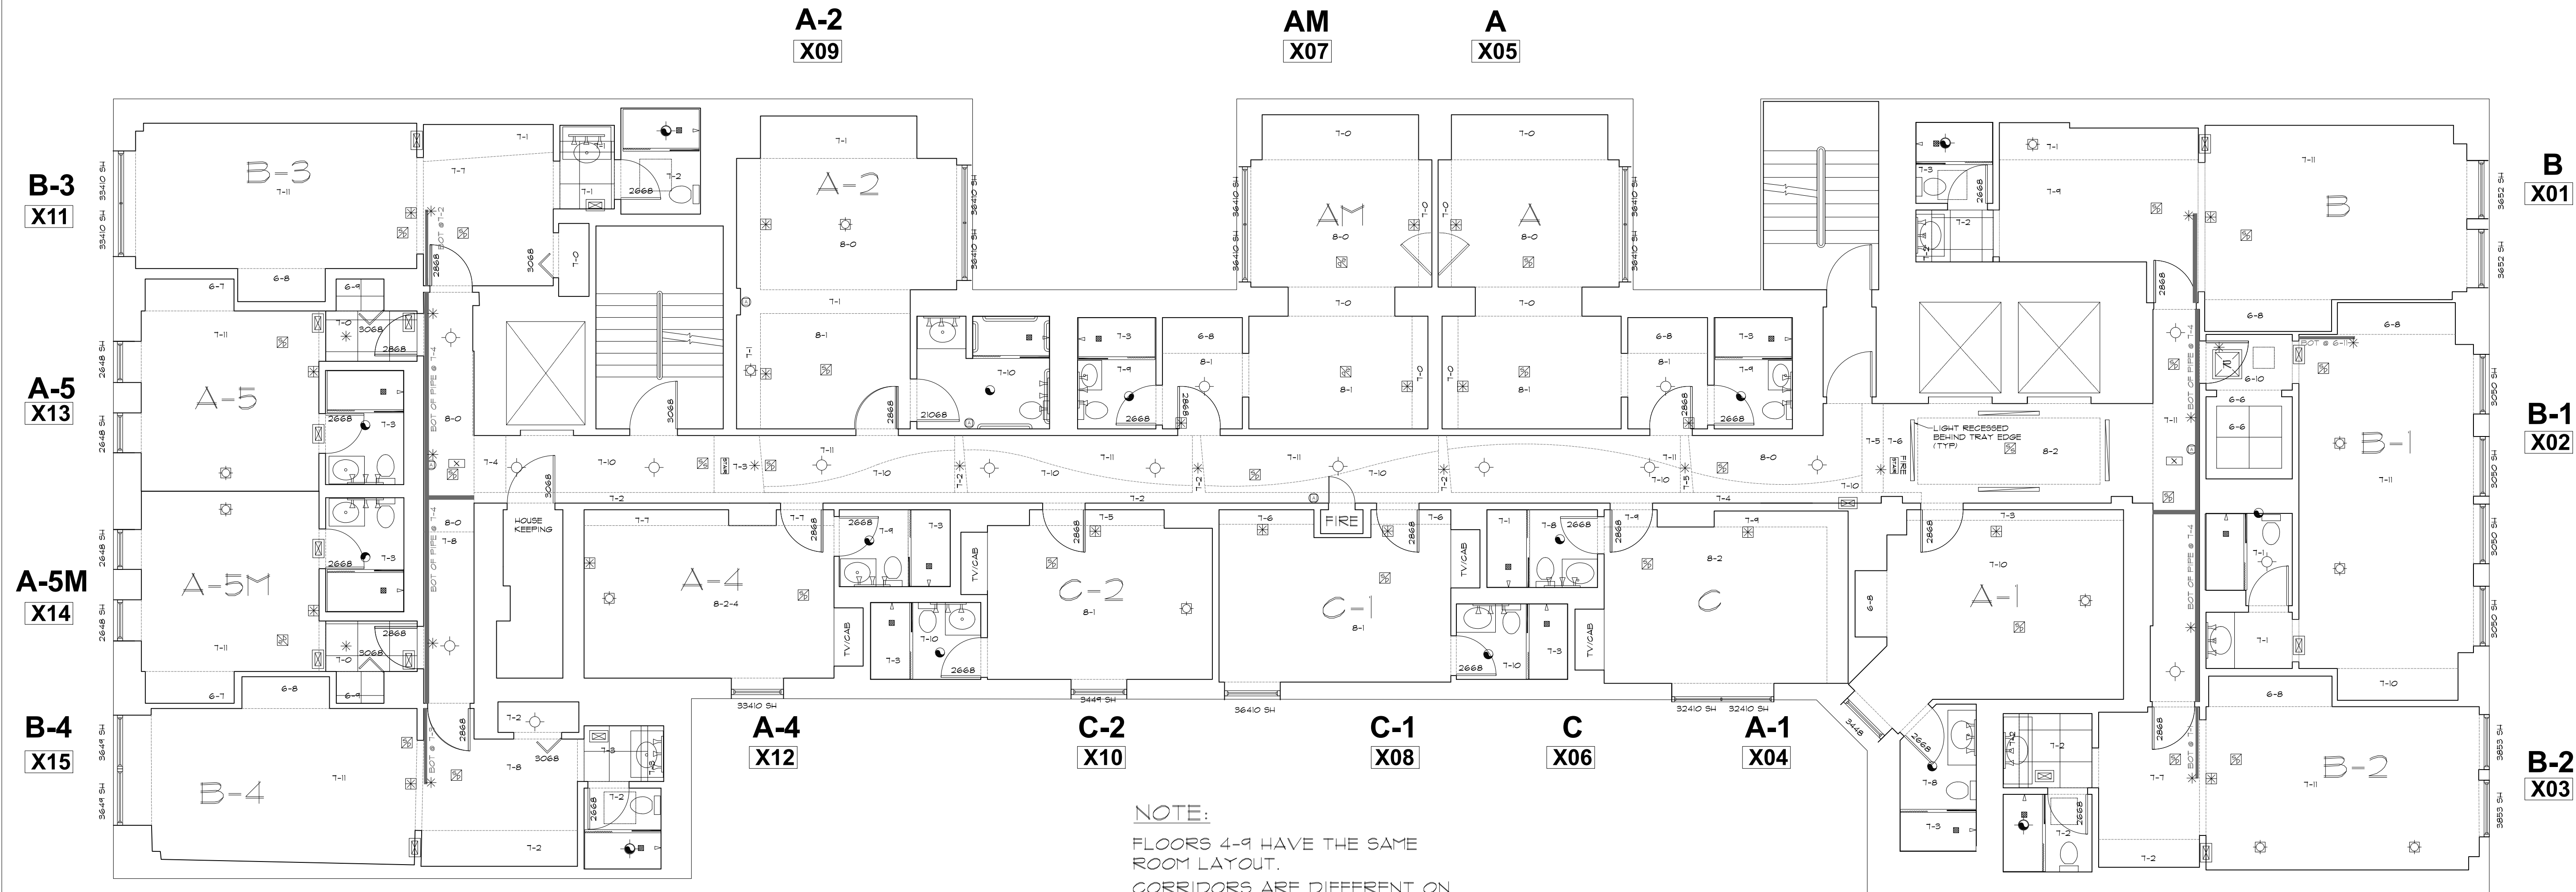

NOTE:
FLOORS 4-9 HAVE THE SAME
ROOM LAYOUT.
CORRIDORS ARE DIFFERENT ON
EVERY FLOOR.

FLOOR 8
3/16"=1'-0"

SYMBOLS LEGEND

RCP			ELECTRIC		FIRE PROTECTION	
	EXHAUST VENT			DATA OUTLET		FIRE EXTINGUISHER
	CEILING MOUNTED LIGHT FIXTURE			TELEPHONE JACK		FIRE PULL
	CEILING MOUNTED DIRECTIONAL LIGHT			ELECTRIC SWITCH		FIRE ALARM (HORN/SRTOKE)
	RECESSED CAN LIGHT			CABLE TELEVISION OUTLET		SMOKE DETECTOR
	EYEBALL OR SMALL CAN LIGHT			DUPLEX RECEPTACLE OUTLET		SMOKE ALARM SPEAKER
	PENDANT LIGHT			SPECIAL PURPOSE CONNECTION OR OUTLET		SPRINKLER HEAD CEILING MOUNT
	INDIVIDUAL FLUOR. LAY-IN FIXTURE 4 BULB			QUADRUPEX RECEPTACLE OUTLET		SPRINKLER HEAD WALL MOUNT
	INDIVIDUAL FLUOR. HANGING FIXTURE 2 BULB			FLOOR DUPLEX RECEPTACLE OUTLET	MEP THERMOSTAT FLOOR DRAIN VALVE HOSE BIB WATER SUPPLY SUSPENDED GAS HEATER	
	INDIVIDUAL FLUOR. FLUSH MOUNT FIXTURE 4 BULB			ELECTRIC PANEL		
	CAMERA			ELECTRIC METER		
	MOTION DET.			BUTTON SWITCH		
	SUPPLY VENT	7-2-6 CEILING HEIGHT AND TRIM 7'-2" ABOVE FLOOR BELOW WITH 6" CROWN MOULDING. NOTE: ALL CEILINGS NOT LABELED ARE PLASTER CEILINGS SHOWN WITH A GRID ARE LAY IN ACOUSTICAL TILE..		DISCONNECT SWITCH	MISC BOLLARD	
	RETURN VENT			GROUND/FLOOR LIGHT		
	RETURN VENT			KEY PAD		
	SPEAKER					

As BUILT

PROFESSIONALS

A DIVISION OF:

AEC

CONSULTANTS INC

www.aecconsultantsinc.com

844.272.8458

© 2016 AEC CONSULTANTS INC

ARCHITECTURAL AS BUILT

HOTEL INDIGO

CHICAGO, IL 60610

01

100% SUBMISSION

NO.

ISSUES | REVISIONS

DATE

SHEET TITLE

HL

PROJECT MANAGER

HL

PROJECT DIRECTOR

9-2-16-1

PROJECT NUMBER

AS NOTED


SCALE

CL

DRAWN BY

SHEET NUMBER

AB-9

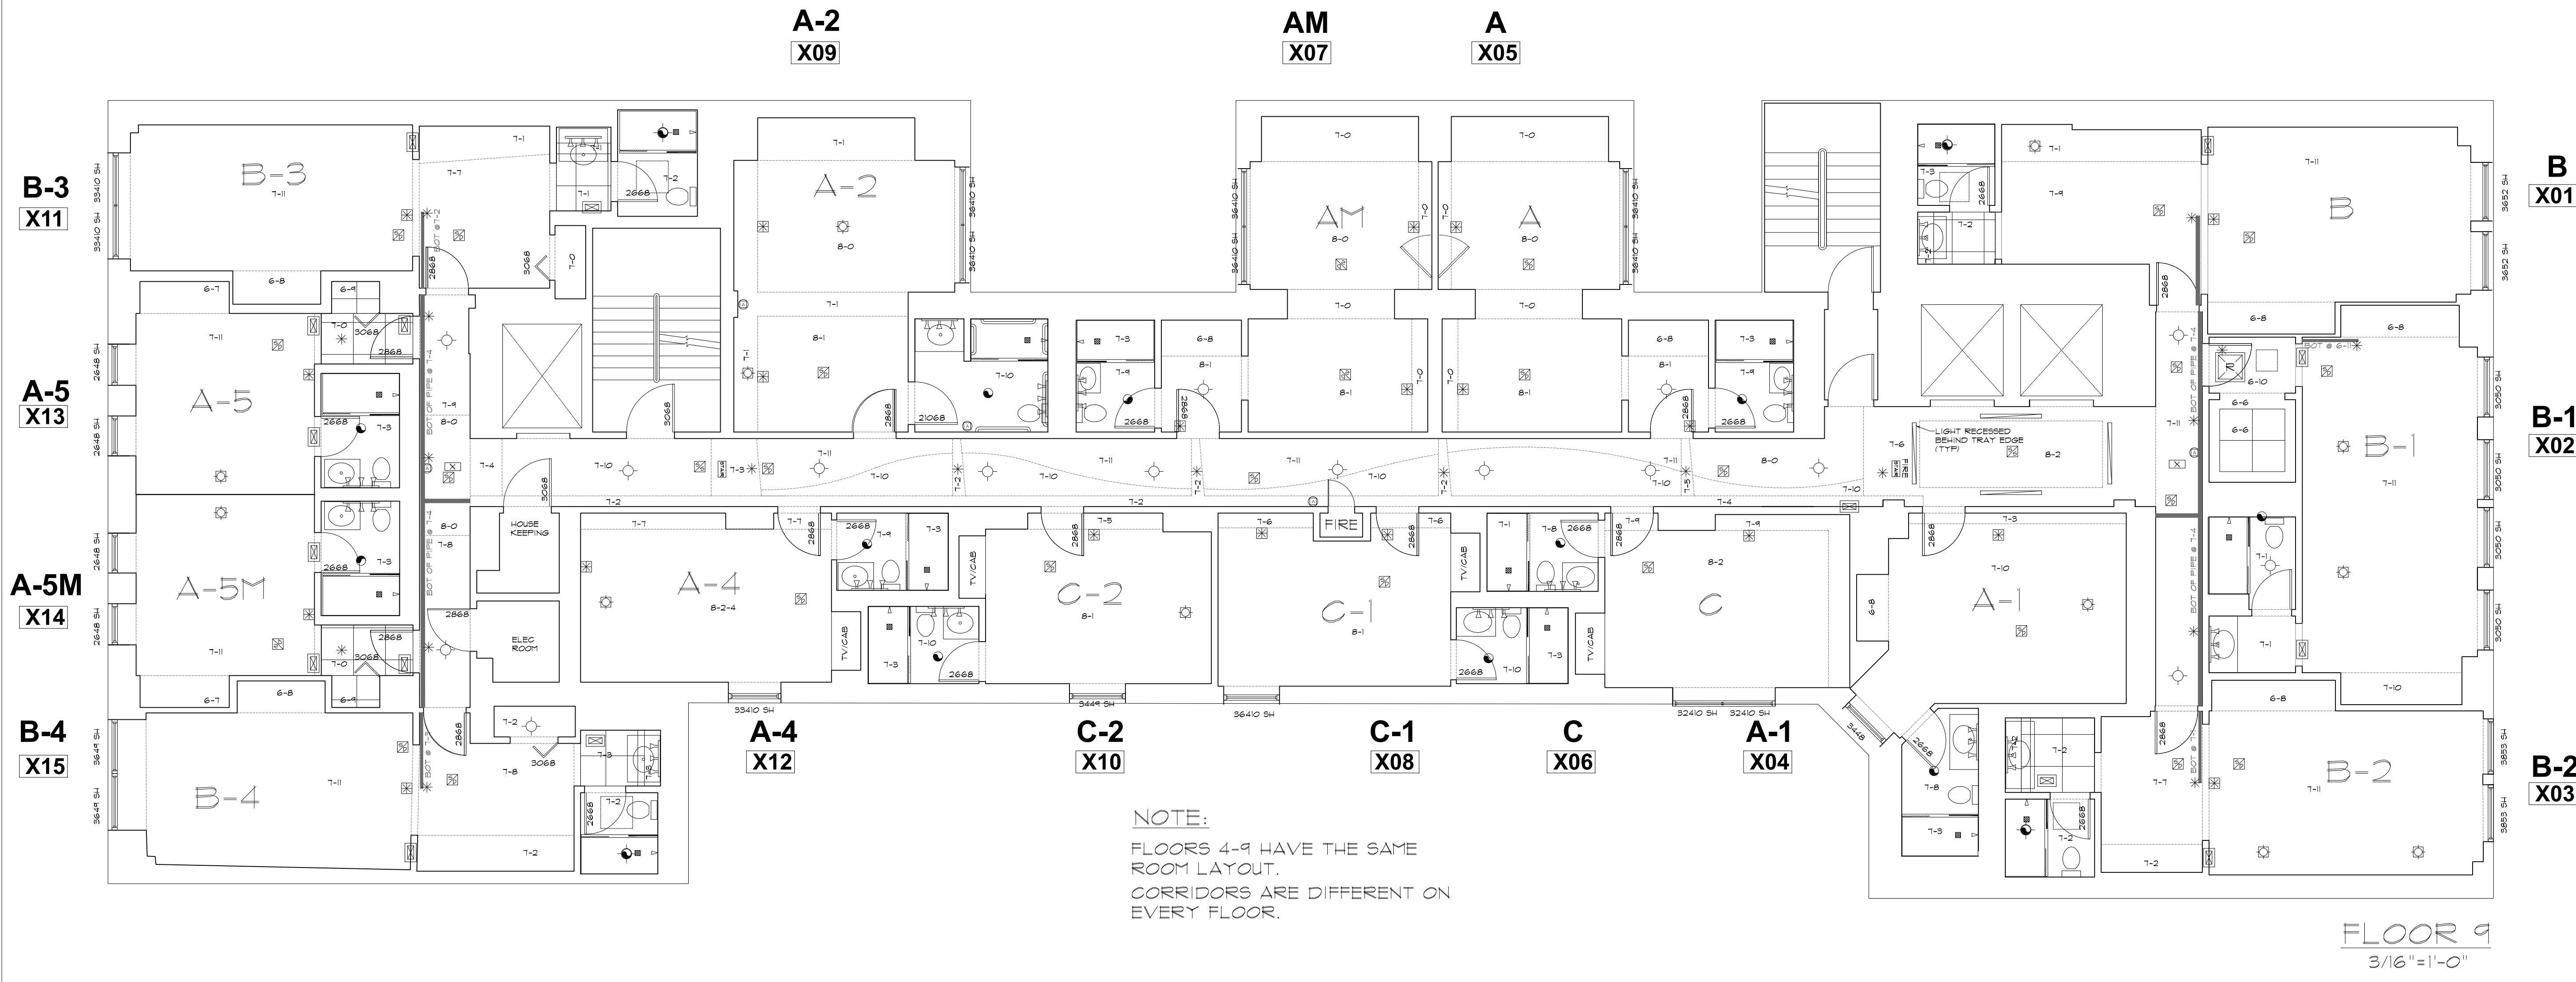

SYMBOLS LEGEND					
RCP			ELECTRIC		FIRE PROTECTION
	EXHAUST VENT			DATA OUTLET	FIRE EXTINGUISHER
	CEILING MOUNTED LIGHT FIXTURE			TELEPHONE JACK	FIRE PULL
	CEILING MOUNTED DIRECTIONAL LIGHT			ELECTRIC SWITCH	FIRE ALARM (HORN/SRTOKE)
	RECESSED CAN LIGHT			CABLE TELEVISION OUTLET	SMOKE DETECTOR
	EYEBALL OR SMALL CAN LIGHT			DUPLEX RECEPTACLE OUTLET	SMOKE ALARM SPEAKER
	PENDANT LIGHT			SPECIAL PURPOSE CONNECTION OR OUTLET	SPRINKLER HEAD CEILING MOUNT
	INDIVIDUAL FLUOR. LAY-IN FIXTURE 4 BULB			QUADRUPEX RECEPTACLE OUTLET	SPRINKLER HEAD WALL MOUNT
	INDIVIDUAL FLUOR. HANGING FIXTURE 2 BULB			FLOOR DUPLEX RECEPTACLE OUTLET	MEP
	INDIVIDUAL FLUOR. FLUSH MOUNT FIXTURE 4 BULB			ELECTRIC PANEL	
	CAMERA			ELECTRIC METER	
	MOTION DET.			BUTTON SWITCH	
	SUPPLY VENT			DISCONNECT SWITCH	THERMOSTAT
	RETURN VENT			GROUND/FLOOR LIGHT	FLOOR DRAIN
	RETURN VENT			KEY PAD	VALVE
	SPEAKER				HOSE BIB
					WATER SUPPLY
					SUSPENDED GAS HEATER
					MISC
					BOLLARD

AS BUILT
PROFESSIONALS

A DIVISION OF:

AEC

CONSULTANTS INC

www.aecconsultantsinc.com

844.272.8458

© 2016 AEC CONSULTANTS INC


ARCHITECTURAL AS BUILT

HOTEL INDIGO






CHICAGO, IL 60610

01	100% SUBMISSION	
NO.	ISSUES REVISIONS	DATE
SHEET TITLE		
HL	PROJECT MANAGER	
HL	PROJECT DIRECTOR	
9-2-16-1	PROJECT NUMBER	
AS NOTED	SCALE	
CL	DRAWN BY	
SHEET NUMBER		

AB-10

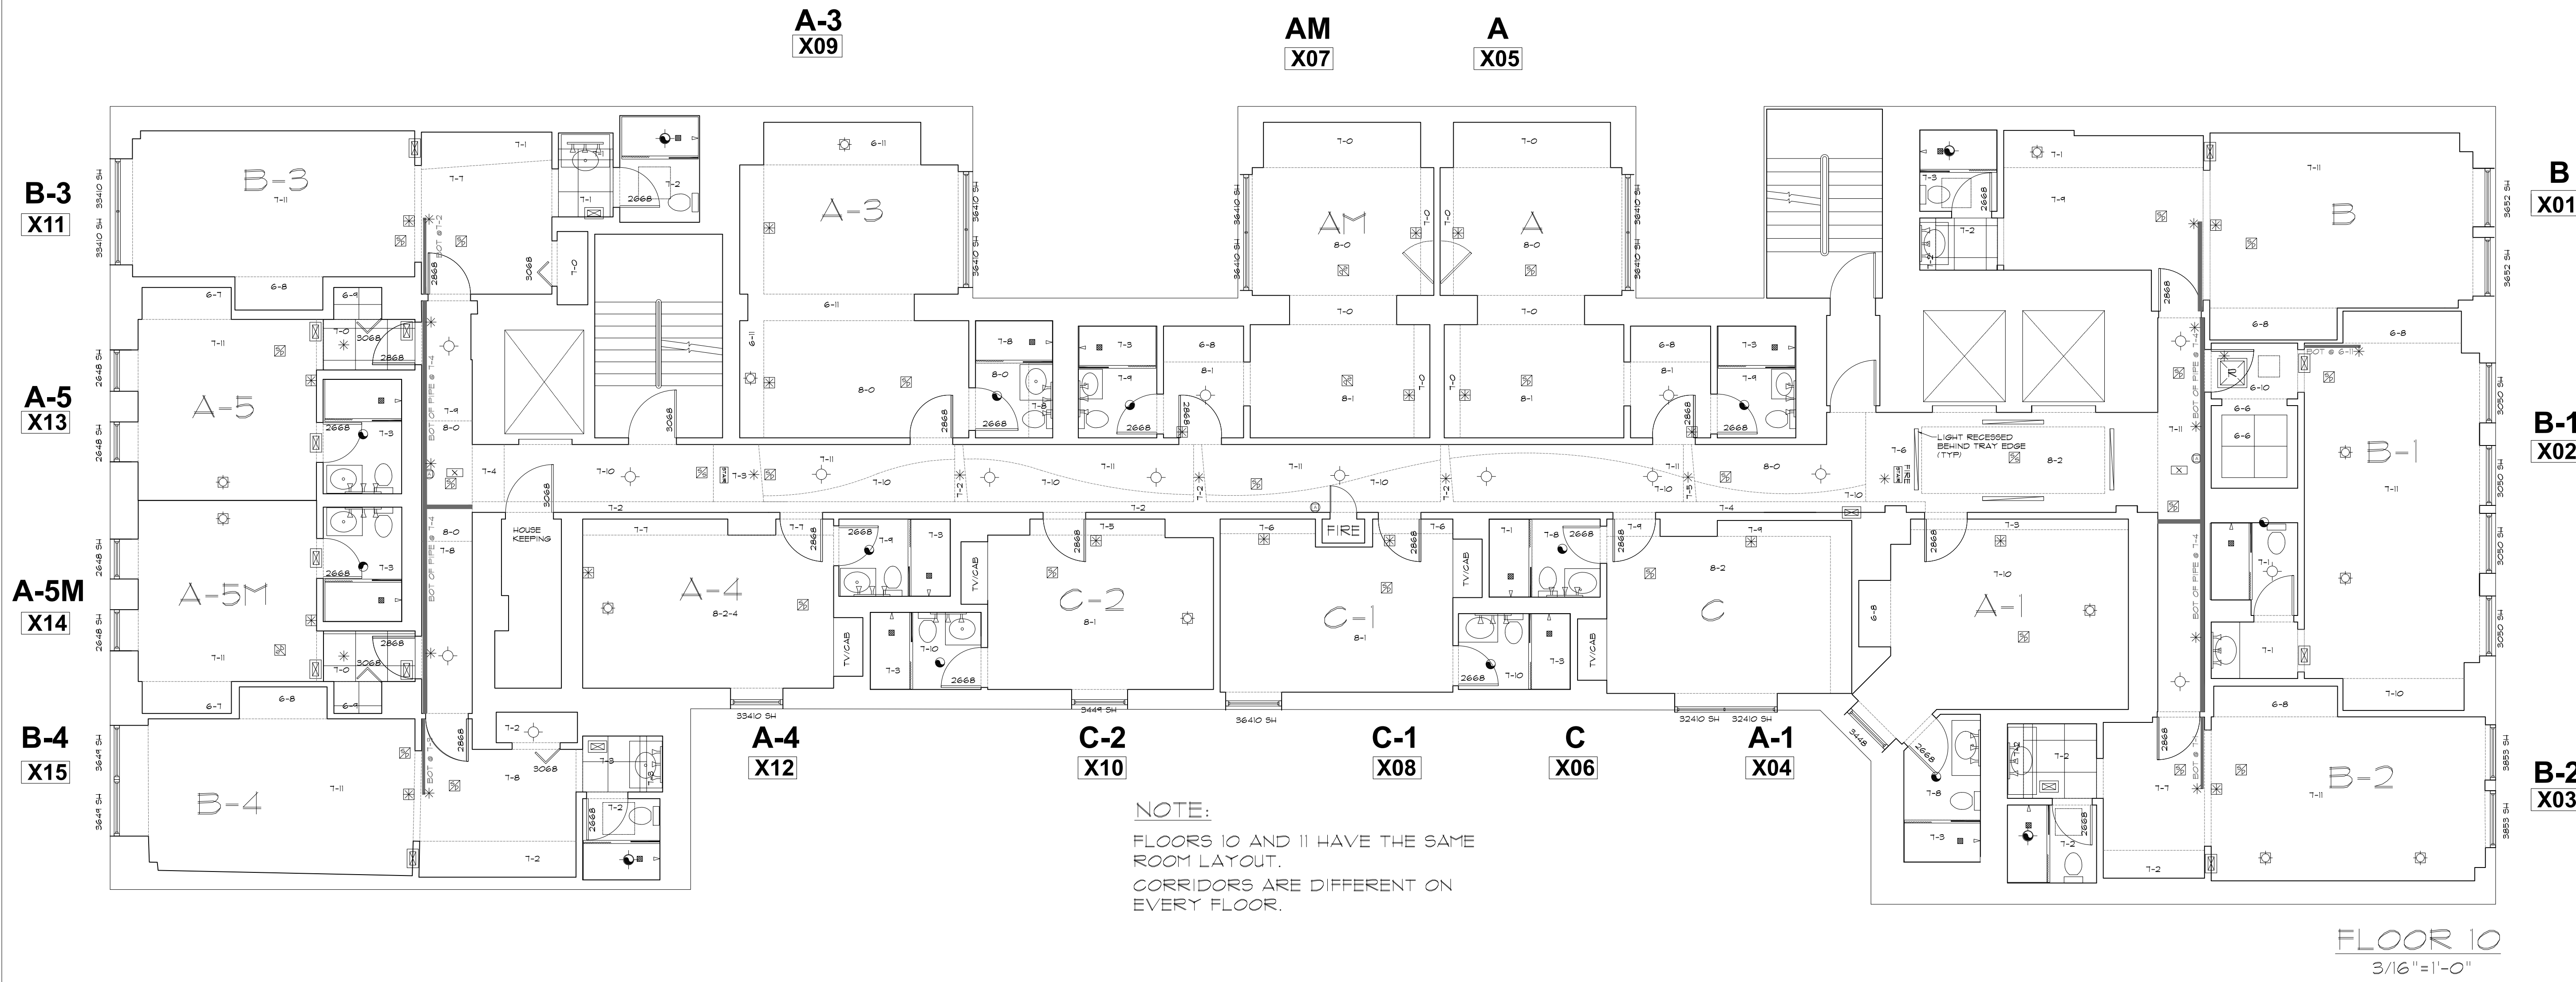

SYMBOLS LEGEND

     RCP		ELECTRIC		FIRE PROTECTION	
	EXHAUST VENT		TRACK LIGHT OR VANITY LIGHT		FIRE EXTINGUISHER
	CEILING MOUNTED LIGHT FIXTURE		WALL-MOUNTED LIGHT FIXTURE		FIRE PULL
	CEILING MOUNTED DIRECTIONAL LIGHT		EMERGENCY EXIT SIGN		FIRE ALARM (HORN/SRTOBE)
	RECESSED CAN LIGHT		EMERGENCY EXIT LIGHT		SMOKE DETECTOR
	EYEBALL OR SMALL CAN LIGHT		EMERGENCY EXIT LIGHT W/ SIGN		SMOKE ALARM SPEAKER
	PENDANT LIGHT		LIGHTED STAIR SIGN		SPRINKLER HEAD CEILING MOUNT
	INDIVIDUAL FLUOR. LAY-IN FIXTURE 4 BULB		FLOOD LIGHT		SPRINKLER HEAD WALL MOUNT
	INDIVIDUAL FLUOR. HANGING FIXTURE 2 BULB		PHOTO CELL	MEP	
	INDIVIDUAL FLUOR. FLUSH MOUNT FIXTURE 4 BULB		CEILING FAN		
	CAMERA		CEILING FAN W/ LIGHT KIT		
	MOTION DET.	7-2-6 CEILING HEIGHT AND TRIM 7'-2" ABOVE FLOOR BELOW WITH 6" CROWN MOULDING. NOTE: ALL CEILINGS NOT LABELED ARE PLASTER CEILINGS SHOWN WITH A GRID ARE LAY IN ACOUSTICAL TILE..			
	SUPPLY VENT				JUNCTION BOX
	SUPPLY VENT				
	RETURN VENT				
	RETURN VENT				
	SPEAKER				



ARCHITECTURAL AS BUILT HOTEL INDIGO CHICAGO, IL 60610

01	100% SUBMISSION	
NO.	ISSUES REVISIONS	DATE
SHEET TITLE		
HL	PROJECT MANAGER	
HL	PROJECT DIRECTOR	
9-2-16-1	PROJECT NUMBER	
AS NOTED	SCALE	
CL	DRAWN BY	
SHEET NUMBER		
AB-11		




FLOOR 12
3/16"=1'-0"



ARCHITECTURAL AS BUILT
HOTEL INDIGO
CHICAGO, IL 60611

01	100% SUBMISSION	
NO.	ISSUES REVISIONS	DATE
		SHEET TITLE
HL	PROJECT MANAGER	
HL	PROJECT DIRECTOR	
9-2-16-1		PROJECT NUMBER
AS NOTED		SCALE
CL		DRAWN BY
		SHEET NUMBER
AB-13		

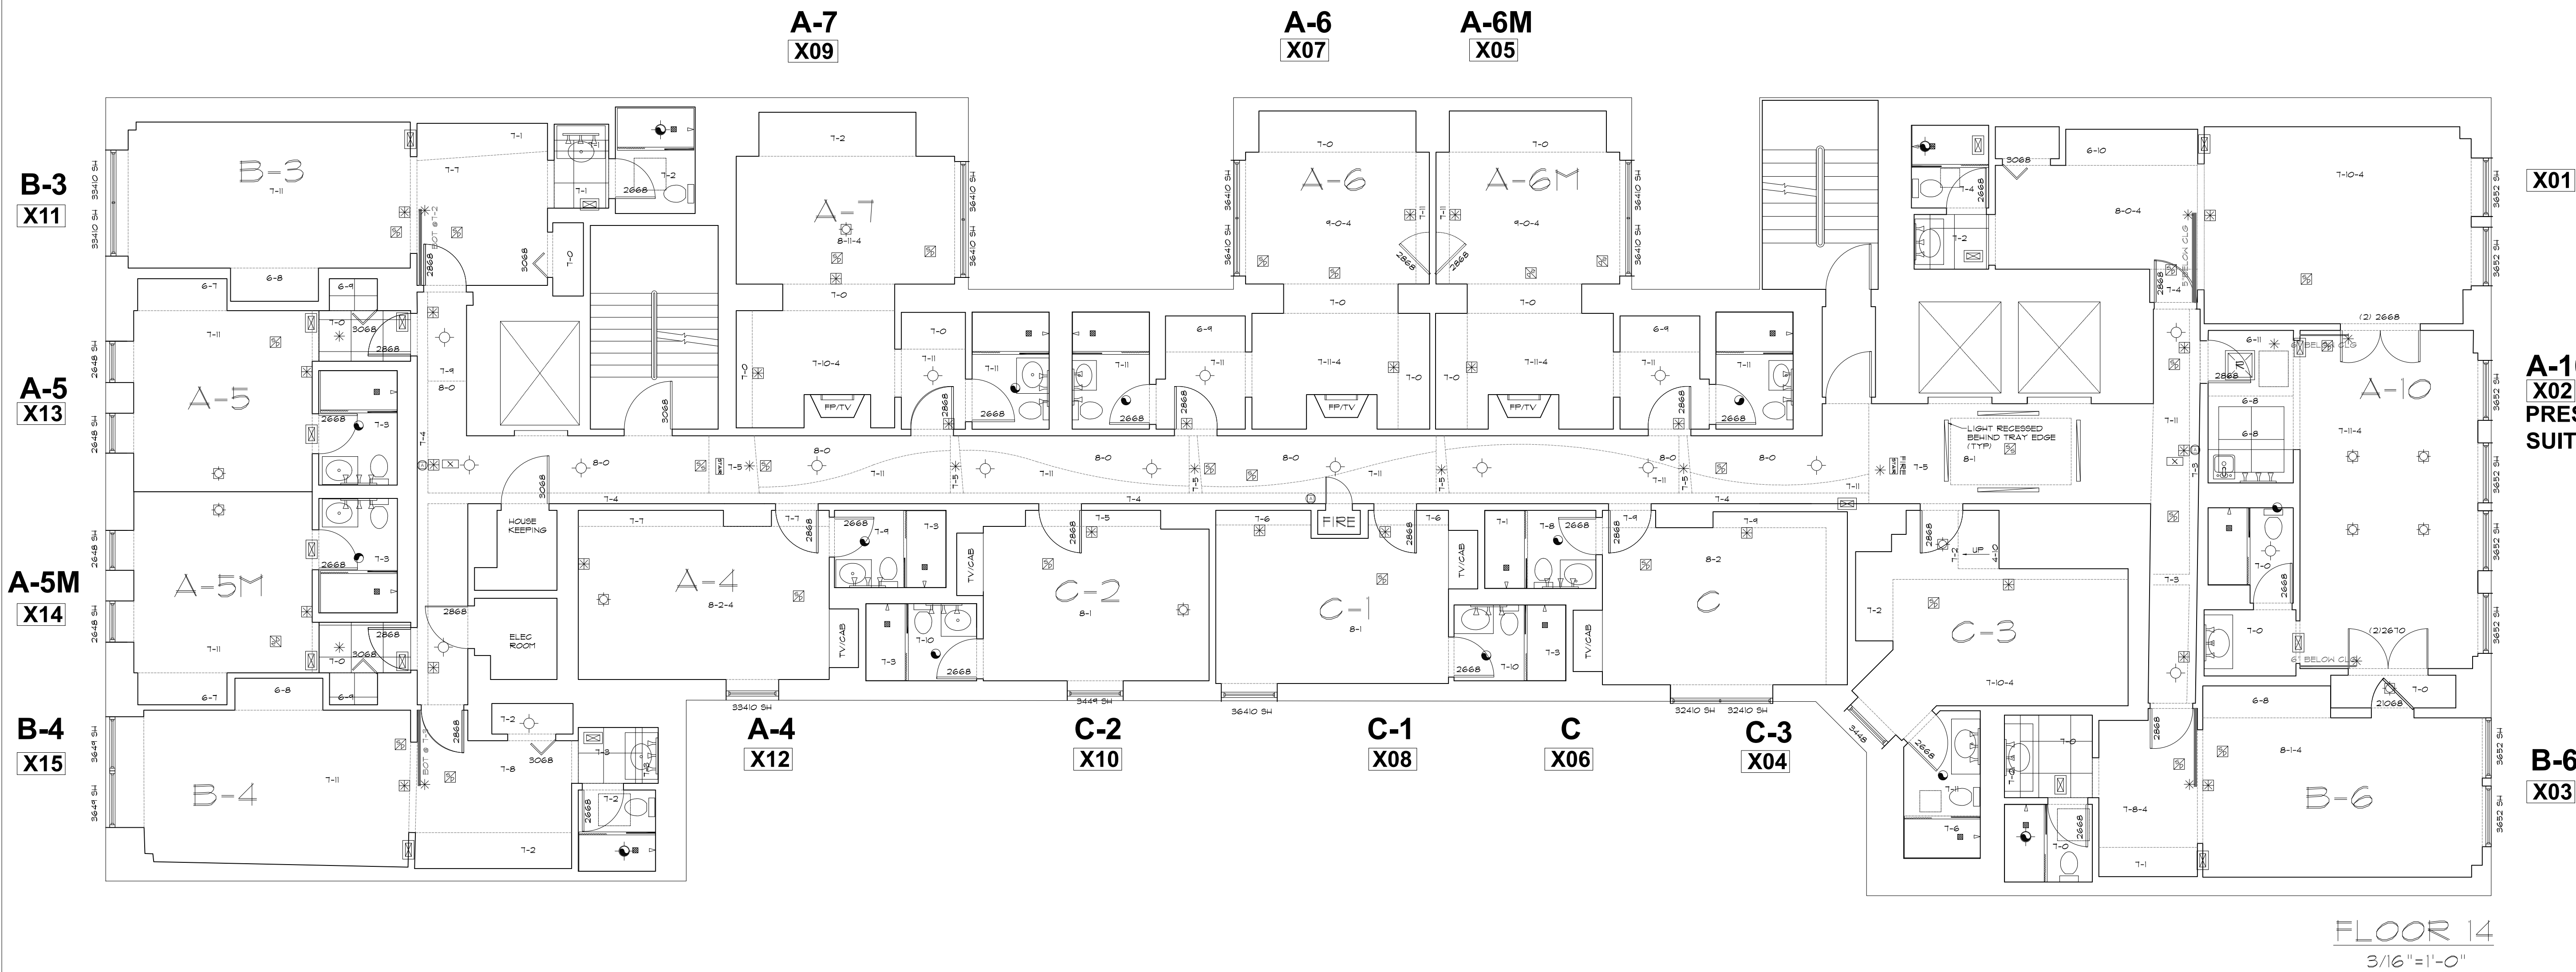

AS BUILT
PROFESSIONALS

A DIVISION OF:

AEC
CONSULTANTS INC

www.aecconsultantsinc.com

844.272.8458

© 2016 AEC CONSULTANTS INC

ARCHITECTURAL AS BUILT

HOTEL INDIGO

CHICAGO, IL 60610

SYMBOLS LEGEND					
RCP			ELECTRIC		FIRE PROTECTION
	EXHAUST VENT			FIRE EXTINGUISHER	
	CEILING MOUNTED LIGHT FIXTURE			FIRE PULL	
	CEILING MOUNTED DIRECTIONAL LIGHT			FIRE ALARM (HORN/SRTOKE)	
	RECESSED CAN LIGHT			SMOKE DETECTOR	
	EYEBALL OR SMALL CAN LIGHT			SMOKE ALARM SPEAKER	
	PENDANT LIGHT			SPRINKLER HEAD CEILING MOUNT	
	INDIVIDUAL FLUOR. LAY-IN FIXTURE 4 BULB			SPRINKLER HEAD WALL MOUNT	
	INDIVIDUAL FLUOR. HANGING FIXTURE 2 BULB			MEP THERMOSTAT FLOOR DRAIN VALVE HOSE BIB WATER SUPPLY SUSPENDED GAS HEATER	
	INDIVIDUAL FLUOR. FLUSH MOUNT FIXTURE 4 BULB				
	CAMERA				
	MOTION DET.	7-2-6 CEILING HEIGHT AND TRIM 7'-2" ABOVE FLOOR BELOW WITH 6" CROWN MOULDING. NOTE: ALL CEILINGS NOT LABELED ARE PLASTER CEILINGS SHOWN WITH A GRID ARE LAY IN ACOUSTICAL TILE..			
	SUPPLY VENT			MISC BOLLARD	
	RETURN VENT				
	RETURN VENT				
	SPEAKER				

01	100% SUBMISSION	
NO.	ISSUES REVISIONS	DATE
		SHEET TITLE
HL	PROJECT MANAGER	
HL	PROJECT DIRECTOR	
9-2-16-1	PROJECT NUMBER	
AS NOTED	SCALE	
CL	DRAWN BY	
		SHEET NUMBER
AB-14		