

AS-BUILT DOCUMENTATION


LEAVENWORTH, WA 98826



100% SUBMITTAL

DRAWING INDEX

C-1	COVER SHEET DRAWING INDEX
SL	SYMBOLS LEGEND
AB-1	FIRST FLOOR PLAN (BASEMENT)
AB-2	SECOND FLOOR PLAN
AB-3	THIRD FLOOR PLAN
AB-4	EXTERIOR ELEVATIONS
AB-5	EXTERIOR ELEVATIONS
AB-6	SITE PLAN

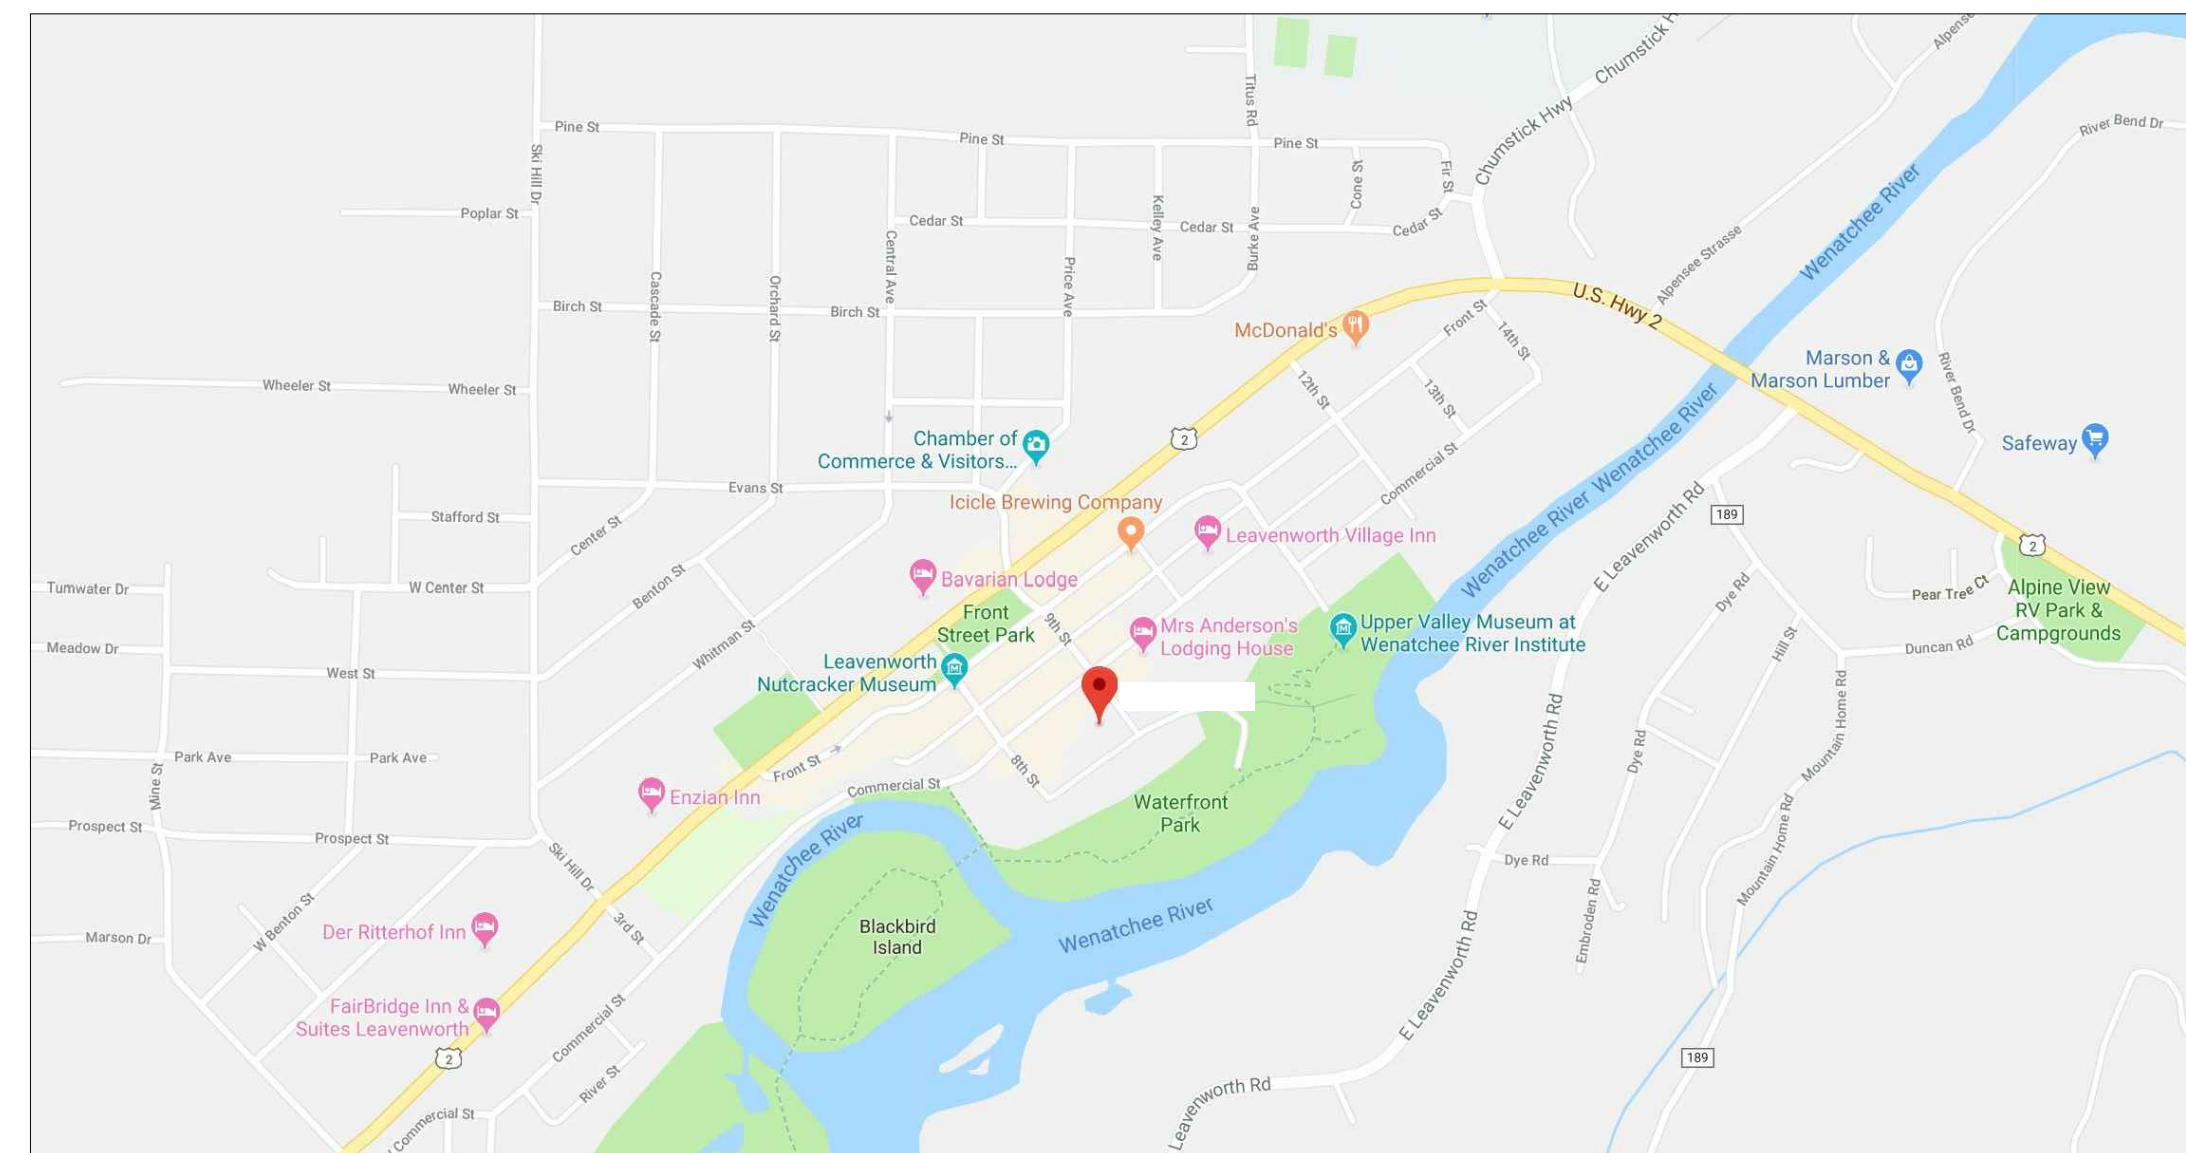

 **VICINITY MAP**
NTS

<u>AREA DATA</u>	
FIRST FLOOR (basement)	9,582 S.F. ±
SECOND FLOOR	8,382 S.F. ±
THIRD FLOOR	7,440 S.F. ±
GRAND TOTAL	25,404 S.F. ±



ARCHITECTURAL AS BUILT

LEAVENWORTH, WA 98826

01	100% SUBMISSION	SEE COVER SHEET
NO.	ISSUES REVISIONS	DATE
		SHEET TITLE

COVER SHEET

HL	PROJECT MANAGER
HL	PROJECT DIRECTOR
012318-1	PROJECT NUMBER
	SCALE
CL	DRAWN BY
	SHEET NUMBER

C-1

SYMBOLS LEGEND

RCP

	EXHAUST VENT		TRACK LIGHT OR VANITY LIGHT
	CEILING MOUNTED LIGHT FIXTURE		WALL-MOUNTED LIGHT FIXTURE
	CEILING MOUNTED DIRECTIONAL LIGHT		EMERGENCY EXIT SIGN
	RECESSED CAN LIGHT		EMERGENCY EXIT LIGHT
	EYEBALL OR SMALL CAN LIGHT		EMERGENCY EXIT LIGHT W/ SIGN
	PENDANT LIGHT		LIGHTED STAIR SIGN
	INDIVIDUAL FLUOR. LAY-IN FIXTURE 4 BULB		FLOOD LIGHT
	INDIVIDUAL FLUOR. HANGING FIXTURE 2 BULB		PHOTO CELL
	INDIVIDUAL FLUOR. FLUSH MOUNT FIXTURE 4 BULB		CEILING FAN
	CAMERA		CEILING FAN W/ LIGHT KIT
	MOTION DET.		7-2-6 CEILING HEIGHT AND TRIM 7'-2" ABOVE FLOOR BELOW WITH 6" CROWN MOULDING. NOTE: ALL CEILINGS NOT LABELED ARE PLASTER. CEILINGS SHOWN WITH A GRID ARE LAY IN ACOUSTICAL TILE..
	SUPPLY VENT		JUNCTION BOX
	SUPPLY VENT		
	RETURN VENT		
	RETURN VENT		
	SPEAKER		

ELECTRIC

	DATA OUTLET
	TELEPHONE JACK
	ELECTRIC SWITCH
	CABLE TELEVISION OUTLET
	DUPLEX RECEPTACLE OUTLET
	SPECIAL PURPOSE CONNECTION OR OUTLET
	QUADRUPLIX RECEPTACLE OUTLET
	FLOOR DUPLEX RECEPTACLE OUTLET
	ELECTRIC PANEL
	ELECTRIC METER
	BUTTON SWITCH
	DISCONNECT SWITCH
	GROUND/FLOOR LIGHT
	KEY PAD

FIRE PROTECTION

	FIRE EXTINGUISHER
	FIRE PULL
	FIRE ALARM (HORN/SRTOBE)
	SMOKE DETECTOR
	SMOKE ALARM SPEAKER
	SPRINKLER HEAD CEILING MOUNT
	SPRINKLER HEAD WALL MOUNT

MEP

	THERMOSTAT
	FLOOR DRAIN
	VALVE
	HOSE BIB
	WATER SUPPLY
	SUSPENDED GAS HEATER

MISC

	BOLLARD
	11-4-11/16 SPOT ELEVATION

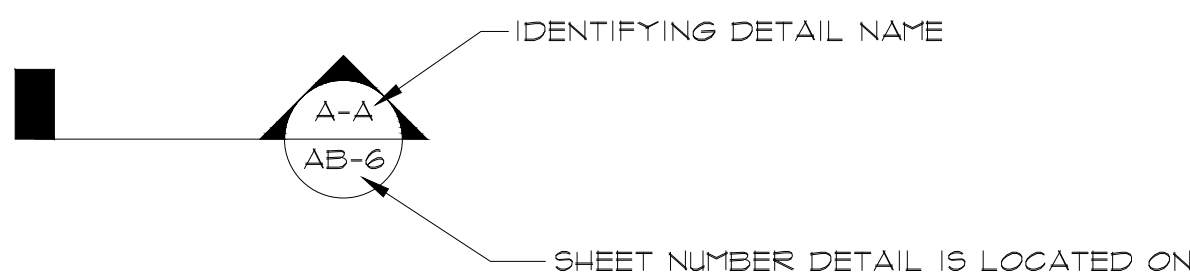
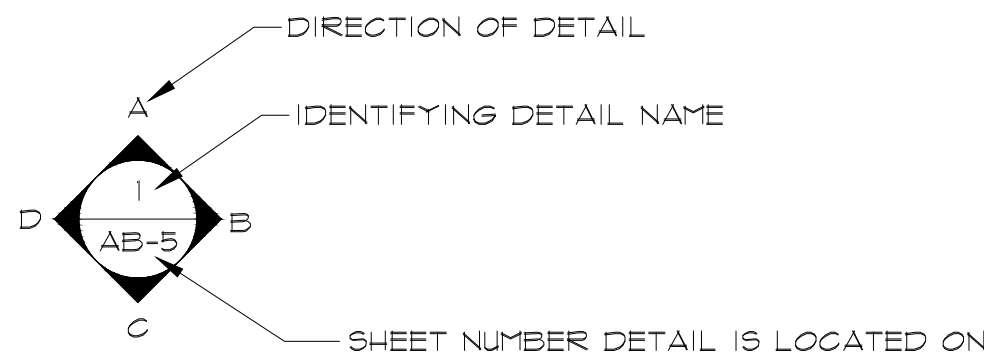


PHOTO DOCUMENTATION LEGEND

INDICATES LOCATION OF CAMERA

INDICATES DIRECTION OF CAMERA LENS AND CORRESPONDING PHOTO / VIDEO NUMBER

TYPES OF DOCUMENTATION

	GROUND BASED PHOTO		GROUND BASED VIDEO		360° SPHERICAL PHOTO		AERIAL BASED PHOTO		AERIAL BASED VIDEO
--	--------------------	--	--------------------	--	----------------------	--	--------------------	--	--------------------

As BUILT PROFESSIONALS
www.asbuiltprofessionals.com
A DIVISION OF:

AEC CONSULTANTS INC
844.272.8458
844 ASBUILT

© 2018 AEC CONSULTANTS INC.

ARCHITECTURAL AS BUILT

LEAVENWORTH, WA 98826

01	100% SUBMISSION	SEE COVER SHEET
NO.	ISSUES REVISIONS	DATE
		SHEET TITLE
HL	PROJECT MANAGER	
HL	PROJECT DIRECTOR	
012318-1		PROJECT NUMBER
NO SCALE		SCALE
CL	DRAWN BY	
		SHEET NUMBER

AB-1



SECOND FLOOR PLAN 8,382 S.F.

As BUILT

PROFESSIONALS

www.asbuiltprofessionals.com

A DIVISION OF:

AEC

CONSULTANTS

INC

844.272.8458

844 ASBUILT

© 2018 AEC CONSULTANTS INC.

ARCHITECTURAL AS BUILT

LEAVENWORTH, WA 98826

01	100% SUBMISSION	SEE COVER SHEET
NO.	ISSUES REVISIONS	DATE
		SHEET TITLE
HL	PROJECT MANAGER	
HL	PROJECT DIRECTOR	
012318-1		PROJECT NUMBER
3/16"=1'-0"		SCALE
CL	DRAWN BY	
		SHEET NUMBER


AB-2




LEAVENWORTH, WA 98826



AB-3

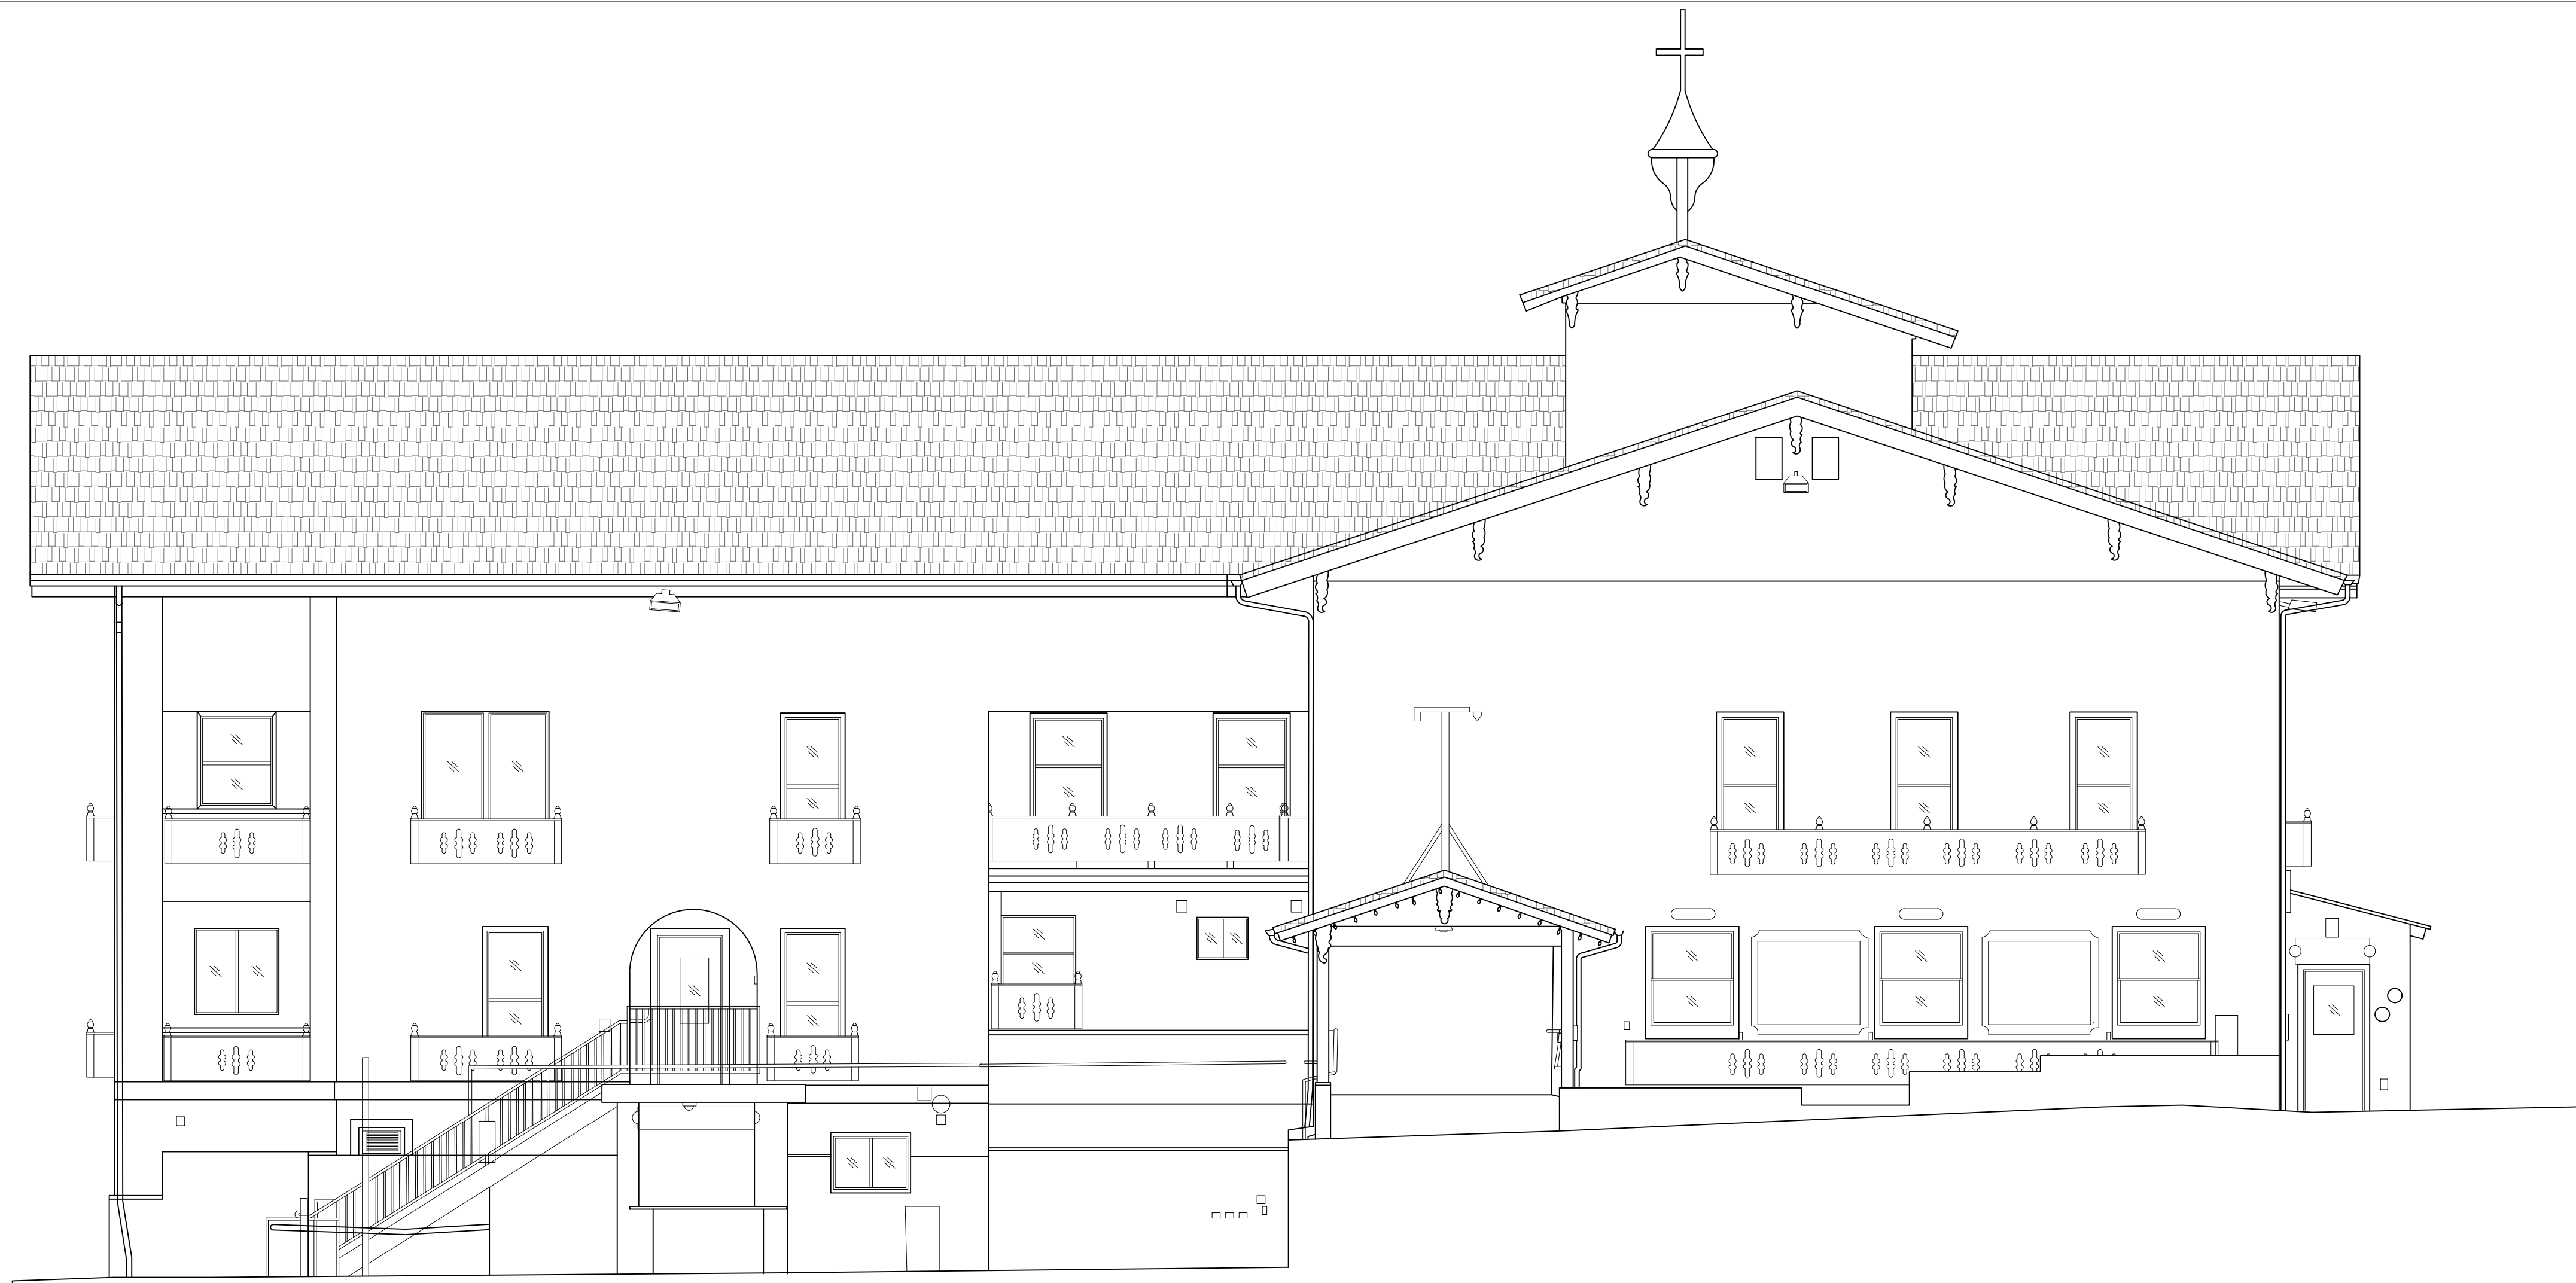

FRONT ELEVATION

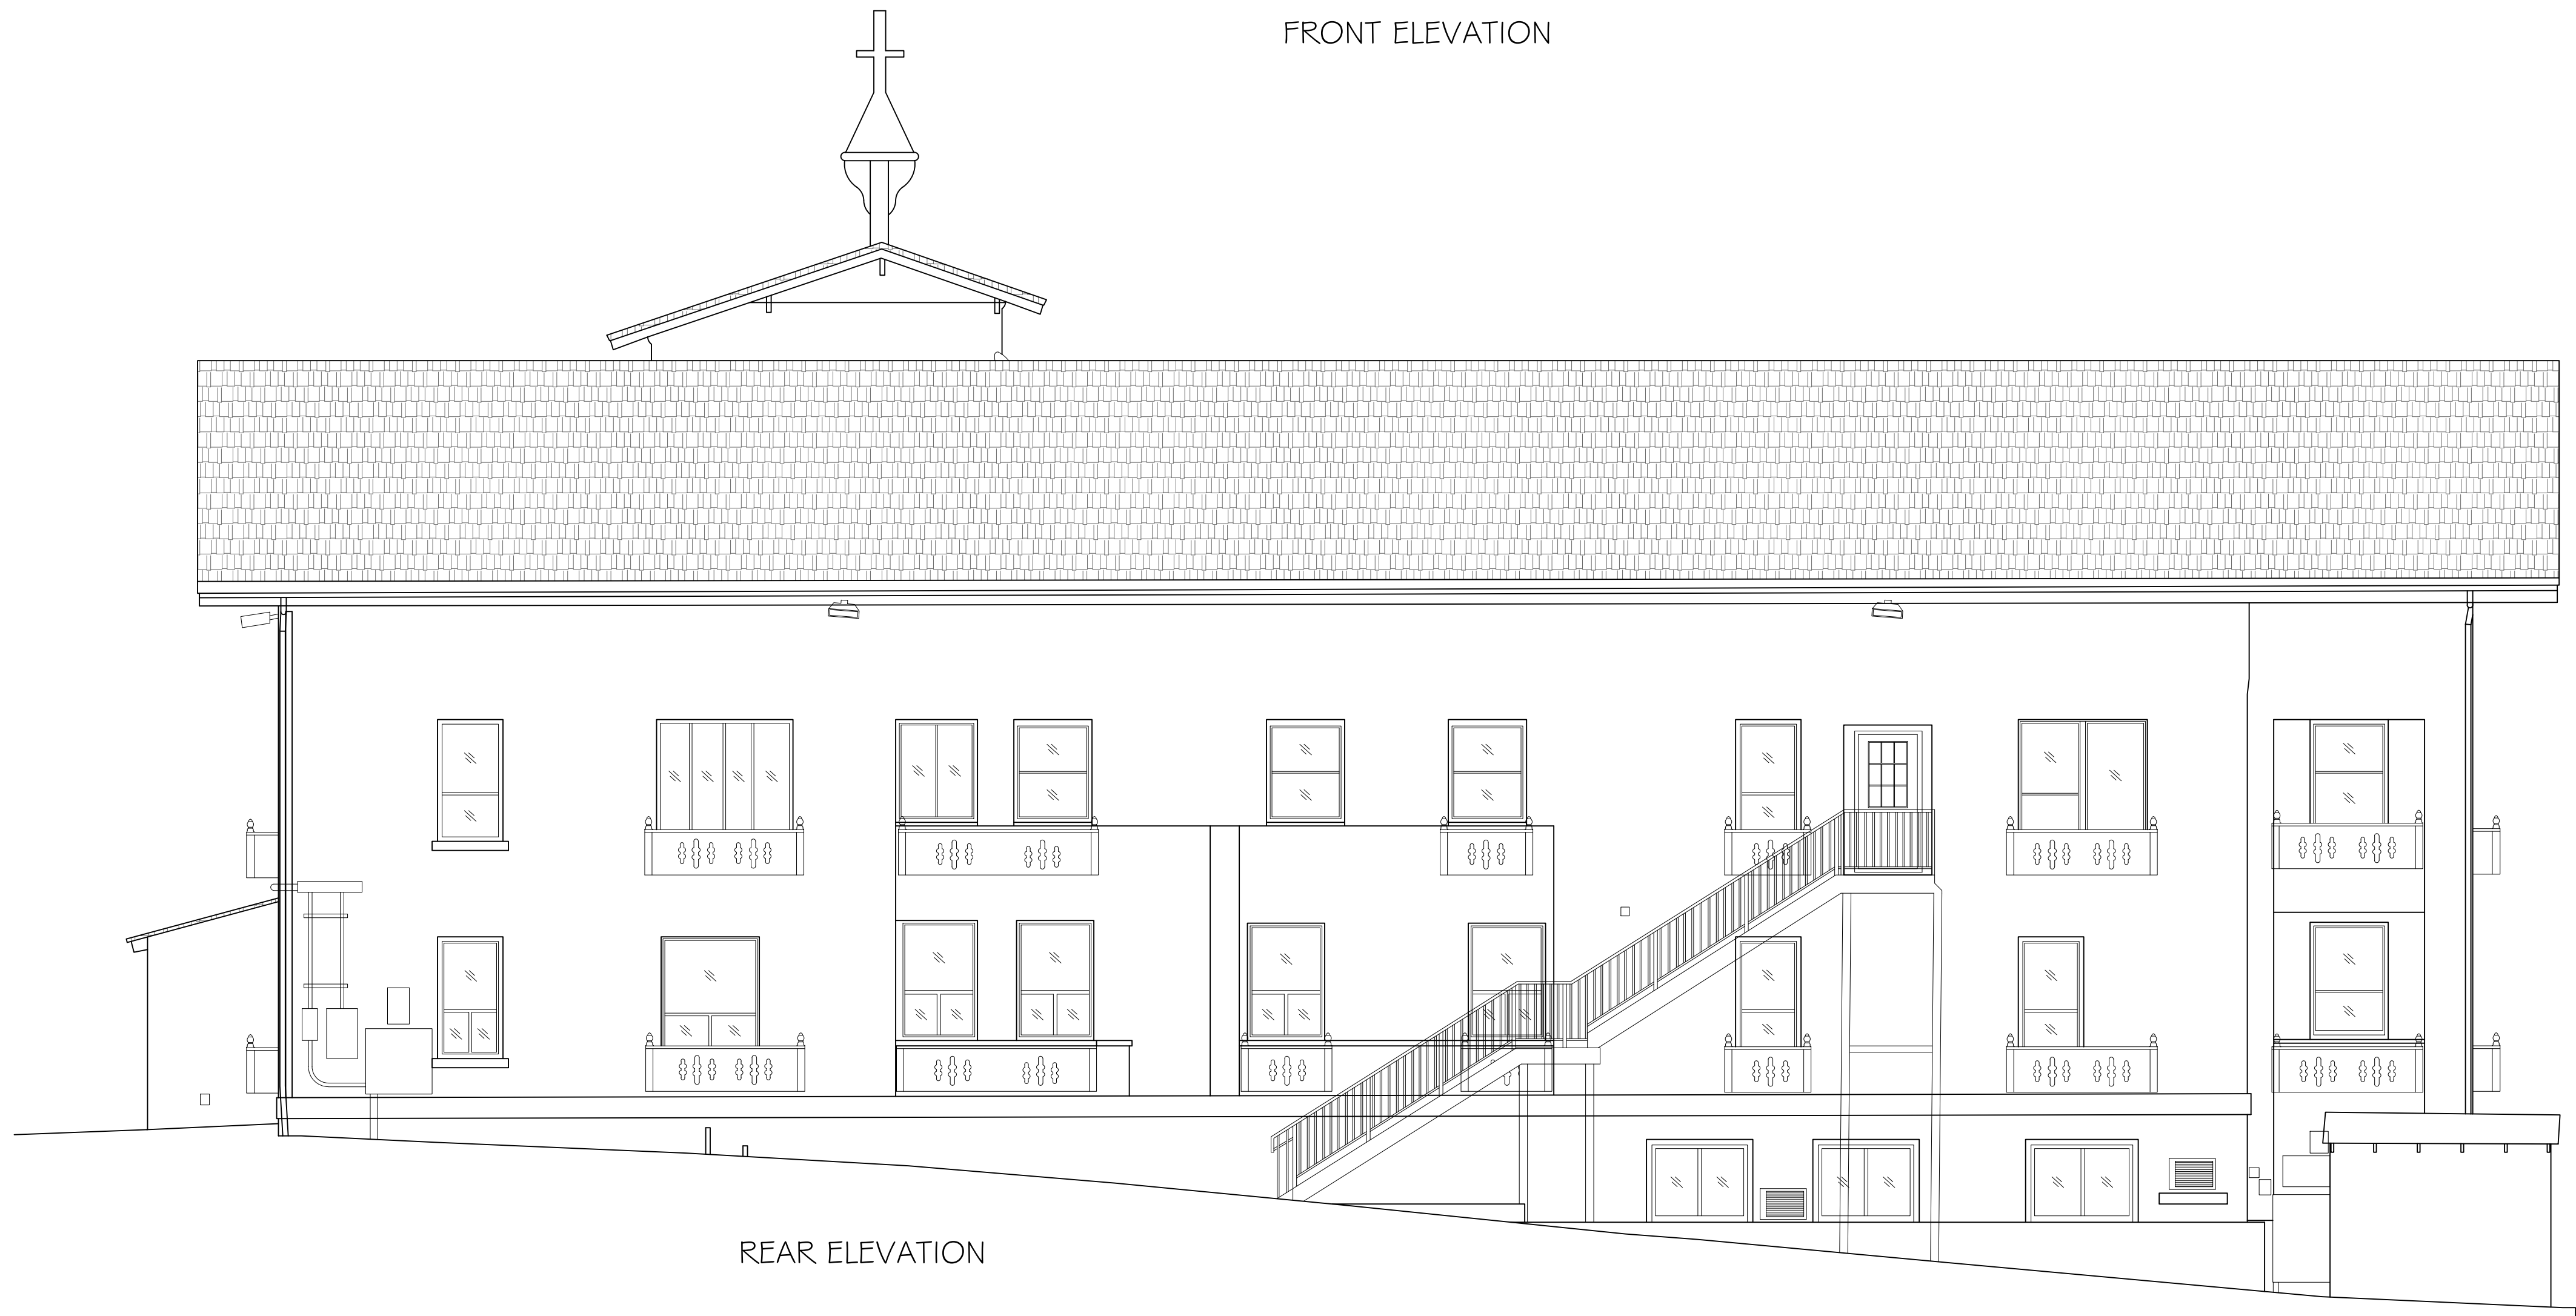

REAR ELEVATION

ARCHITECTURAL AS BUILT

LEAVENWORTH, WA 98826

01	100% SUBMISSION	SEE COVER SHEET
NO.	ISSUES REVISIONS	DATE
		SHEET TITLE
HL	PROJECT MANAGER	
HL	PROJECT DIRECTOR	
012318-1	PROJECT NUMBER	
3/16"=1'-0"	SCALE	
CL	DRAWN BY	
		SHEET NUMBER

AB-5



01	100% SUBMISSION	SEE COVER SHEET
NO.	ISSUES REVISIONS	DATE
		SHEET TITLE
HL	PROJECT MANAGER	
HL	PROJECT DIRECTOR	
012318-1	PROJECT NUMBER	
3/16"=1'-0"	SCALE	
CL	DRAWN BY	
		SHEET NUMBER



LEAVENWORTH, WA 98826

AB-6