

# SYLMAR FACILITY


SYLMAR, CA 91342



100% SUBMITTAL

## DRAWING INDEX

- C-1 COVER SHEET | DRAWING INDEX
- SL SYMBOLS LEGEND
- AB-1 OVERALL FLOOR PLAN
- AB-2 ENLARGED FLOORPLAN DIMENSIONED
- AB-3 ENLARGED FLOORPLAN
- AB-4 ENLARGED FLOORPLAN DIMENSIONED
- AB-5 ENLARGED FLOORPLAN
- AB-6 OVERALL CEILING PLAN
- AB-7 ENLARGED CEILING PLAN DIMENSIONED
- AB-8 ENLARGED CEILING PLAN
- AB-9 ENLARGED CEILING PLAN DIMENSIONED
- AB-10 ENLARGED CEILING PLAN

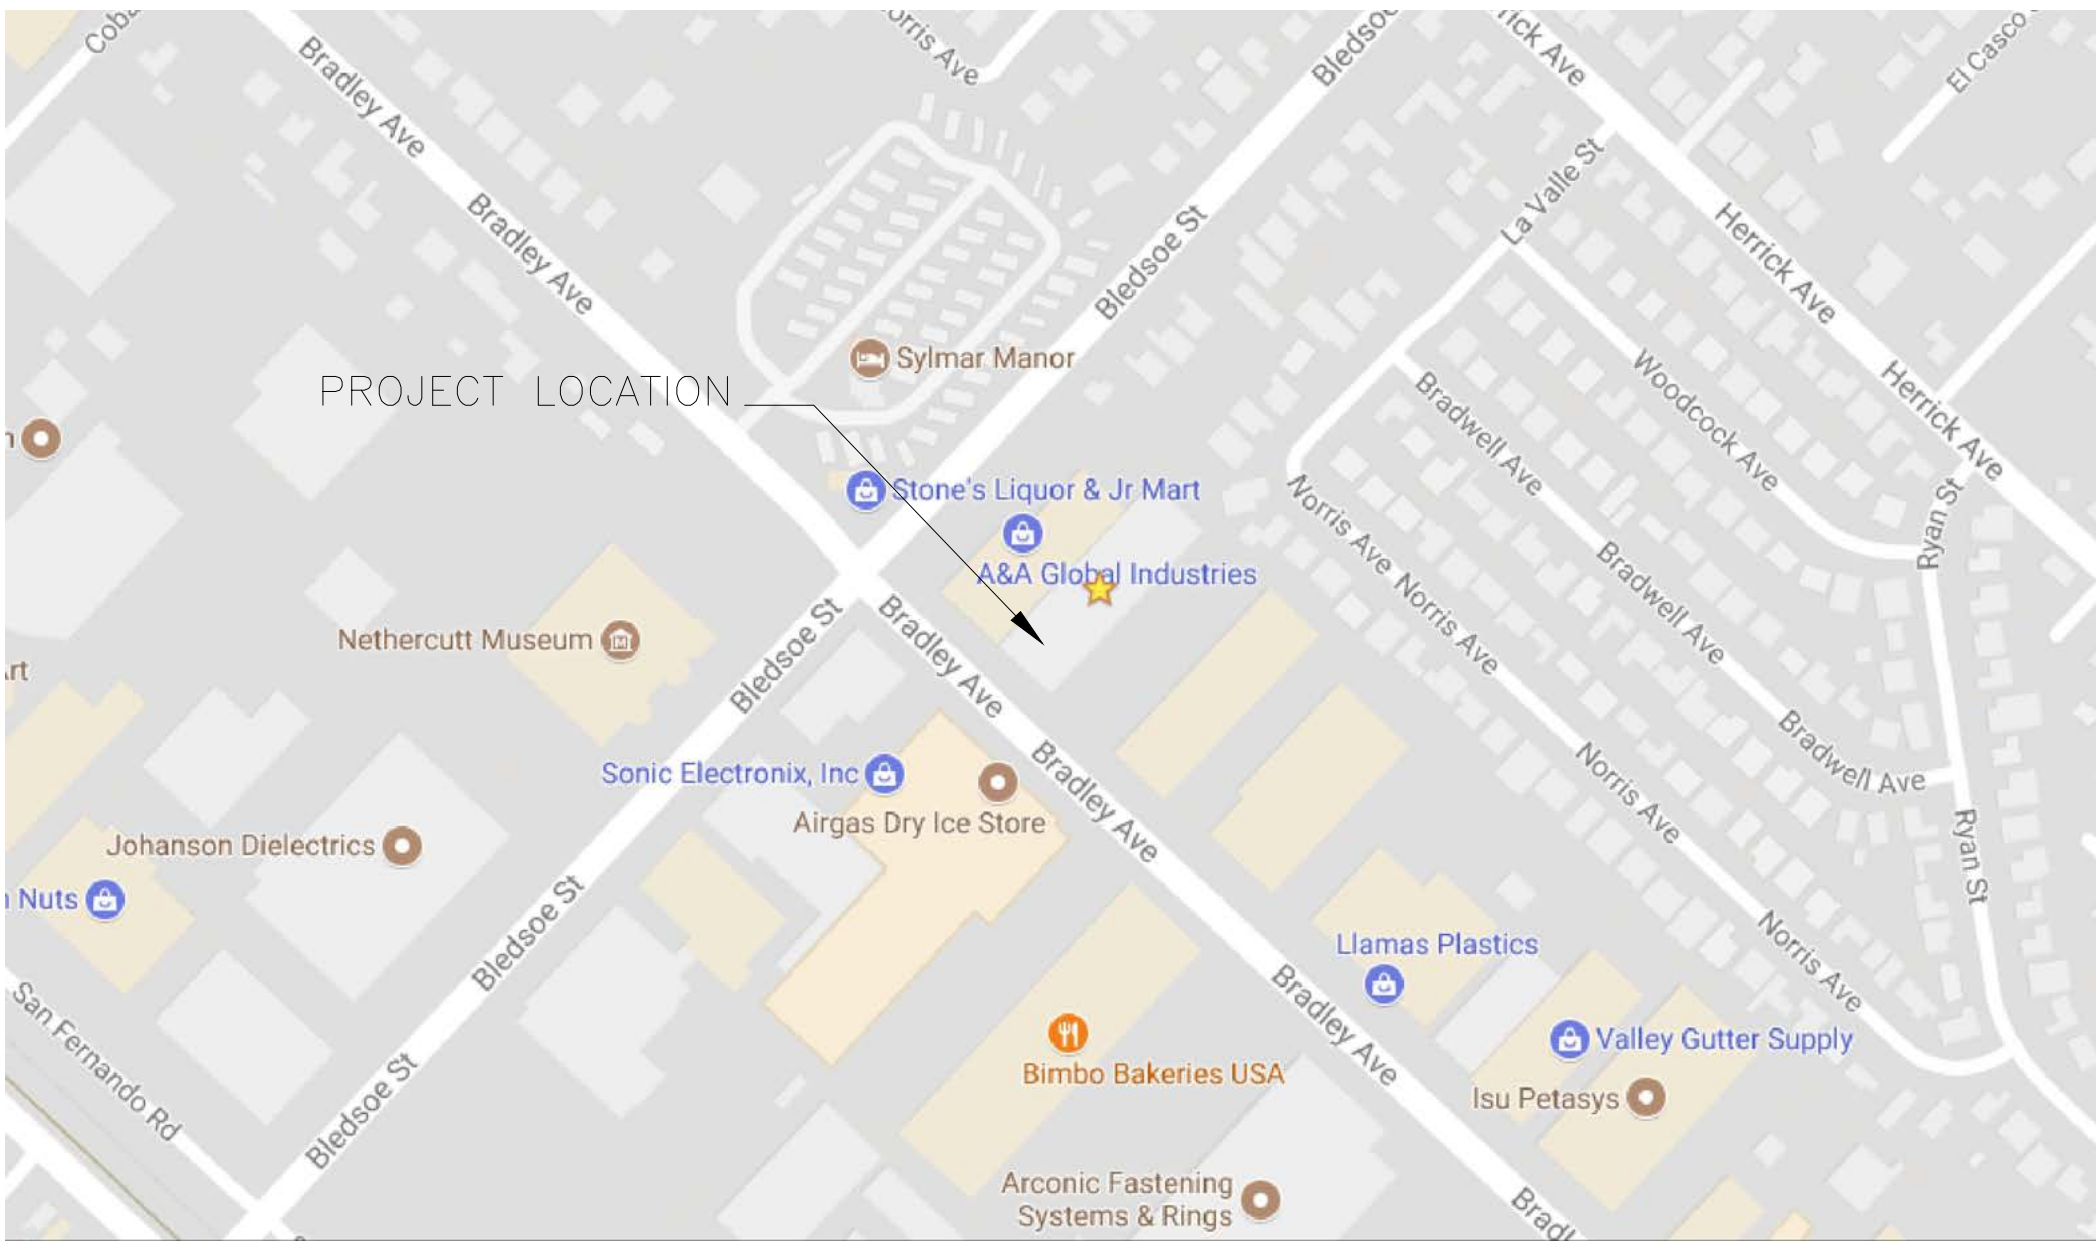

## VICINITY MAP NTS

AREA DATA	
OFFICE/UTILITY	3,414 S.F. ±
WAREHOUSE	35,322 S.F. ±
GRAND TOTAL	38,737 S.F. ±

As BUILT

PROFESSIONALS

www.asbuiltprofessionals.com

A DIVISION OF:

AEC

CONSULTANTS INC

844.272.8458

844 A S B U I L T

© 2017 AEC CONSULTANTS INC

ARCHITECTURAL AS BUILT

SYLMAR CA 91342

COVER SHEET	
HL	PROJECT MANAGER
HL	PROJECT DIRECTOR
	PROJECT NUMBER
	SCALE
MM	DRAWN BY
	SHEET NUMBER
C-1	



SYMBOLS LEGEND

RCP

	EXHAUST VENT		TRACK LIGHT OR VANITY LIGHT
	CEILING MOUNTED LIGHT FIXTURE		WALL-MOUNTED LIGHT FIXTURE
	CEILING MOUNTED DIRECTIONAL LIGHT		EMERGENCY EXIT SIGN
	RECESSED CAN LIGHT		EMERGENCY EXIT LIGHT
	EYEBALL OR SMALL CAN LIGHT		EMERGENCY EXIT LIGHT W/ SIGN
	UTILITY FLORESCENT LIGHT		LIGHTED STAIR SIGN
	INDIVIDUAL FLUOR. LAY-IN FIXTURE 4 BULB		FLOOD LIGHT
	INDIVIDUAL FLUOR. HANGING FIXTURE 2 BULB		PHOTO CELL
	INDIVIDUAL FLUOR. FLUSH MOUNT FIXTURE 4 BULB		CEILING FAN
	SPRINKLER HEAD		CEILING FAN W/ LIGHT KIT
	MOTION DET.		CEILING HEIGHT AND TRIM 7'-2" ABOVE FLOOR BELOW WITH 6" CROWN MOULDING. NOTE: ALL CEILINGS NOT LABELED ARE PLASTER. CEILINGS SHOWN WITH A GRID ARE LAY IN ACOUSTICAL TILE..
	SUPPLY VENT		JUNCTION BOX
	SUPPLY VENT		
	RETURN VENT		
	RETURN VENT		
	SPEAKER		

ELECTRIC

	DATA OUTLET
	TELEPHONE JACK
	ELECTRIC SWITCH
	CABLE TELEVISION OUTLET
	DUPLEX RECEPTACLE OUTLET
	SPECIAL PURPOSE CONNECTION OR OUTLET
	QUADRUPLIX RECEPTACLE OUTLET
	FLOOR DUPLEX RECEPTACLE OUTLET
	ELECTRIC PANEL
	ELECTRIC METER
	BUTTON SWITCH
	DISCONNECT SWITCH
	GROUND/FLOOR LIGHT
	KEY PAD

FIRE PROTECTION

	FIRE EXTINGUISHER
	FIRE PULL
	FIRE ALARM (HORN/SRTOBE)
	SMOKE DETECTOR
	SMOKE ALARM SPEAKER
	SPRINKLER HEAD CEILING MOUNT
	SPRINKLER HEAD WALL MOUNT

MEP

	THERMOSTAT
	FLOOR DRAIN
	VALVE
	HOSE BIB
	WATER SUPPLY
	SUSPENDED GAS HEATER

MISC

	BOLLARD
--	---------

7-2-6

CEILING HEIGHT AND TRIM 7'-2" ABOVE FLOOR BELOW WITH 6" CROWN MOULDING. NOTE: ALL CEILINGS NOT LABELED ARE PLASTER. CEILINGS SHOWN WITH A GRID ARE LAY IN ACOUSTICAL TILE..

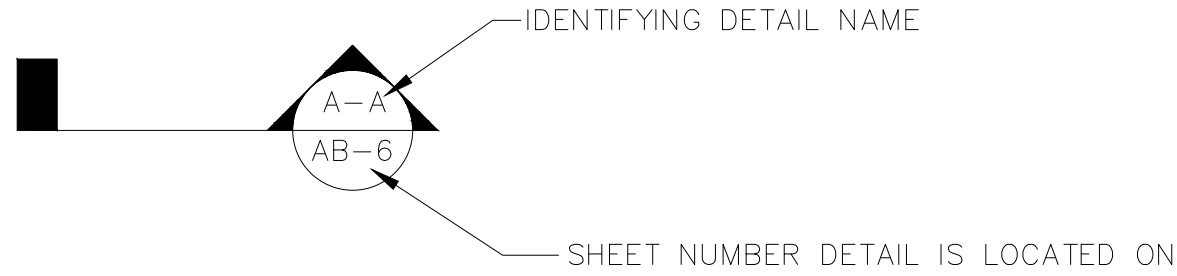
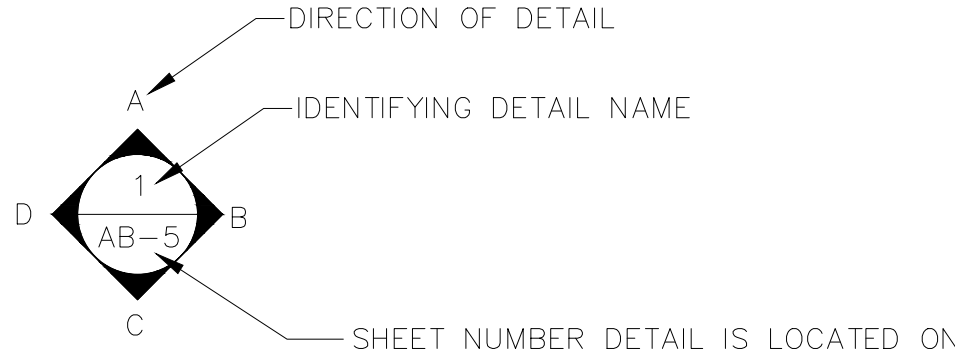


PHOTO DOCUMENTATION LEGEND

INDICATES LOCATION OF CAMERA

INDICATES DIRECTION OF CAMERA LENS AND CORRESPONDING PHOTO / VIDEO NUMBER

TYPES OF DOCUMENTATION

	GROUND BASED PHOTO		GROUND BASED VIDEO		360° SPHERICAL PHOTO		AERIAL BASED PHOTO		AERIAL BASED VIDEO
--	--------------------	--	--------------------	--	----------------------	--	--------------------	--	--------------------

**As BUILT**  
PROFESSIONALS  
www.asbuiltprofessionals.com

A DIVISION OF:

**AEC**  
CONSULTANTS INC


844.272.8458  
844 ASBUILT

© 2017 AEC CONSULTANTS INC

**ARCHITECTURAL AS BUILT**

**SYLMAR CA 91342**

01	100% SUBMISSION	
NO.	ISSUES   REVISIONS	DATE
SHEET TITLE		
HL	PROJECT MANAGER	
HL	PROJECT DIRECTOR	
	PROJECT NUMBER	
NOT TO SCALE		SCALE
MM	DRAWN BY	
	SHEET NUMBER	
SL		

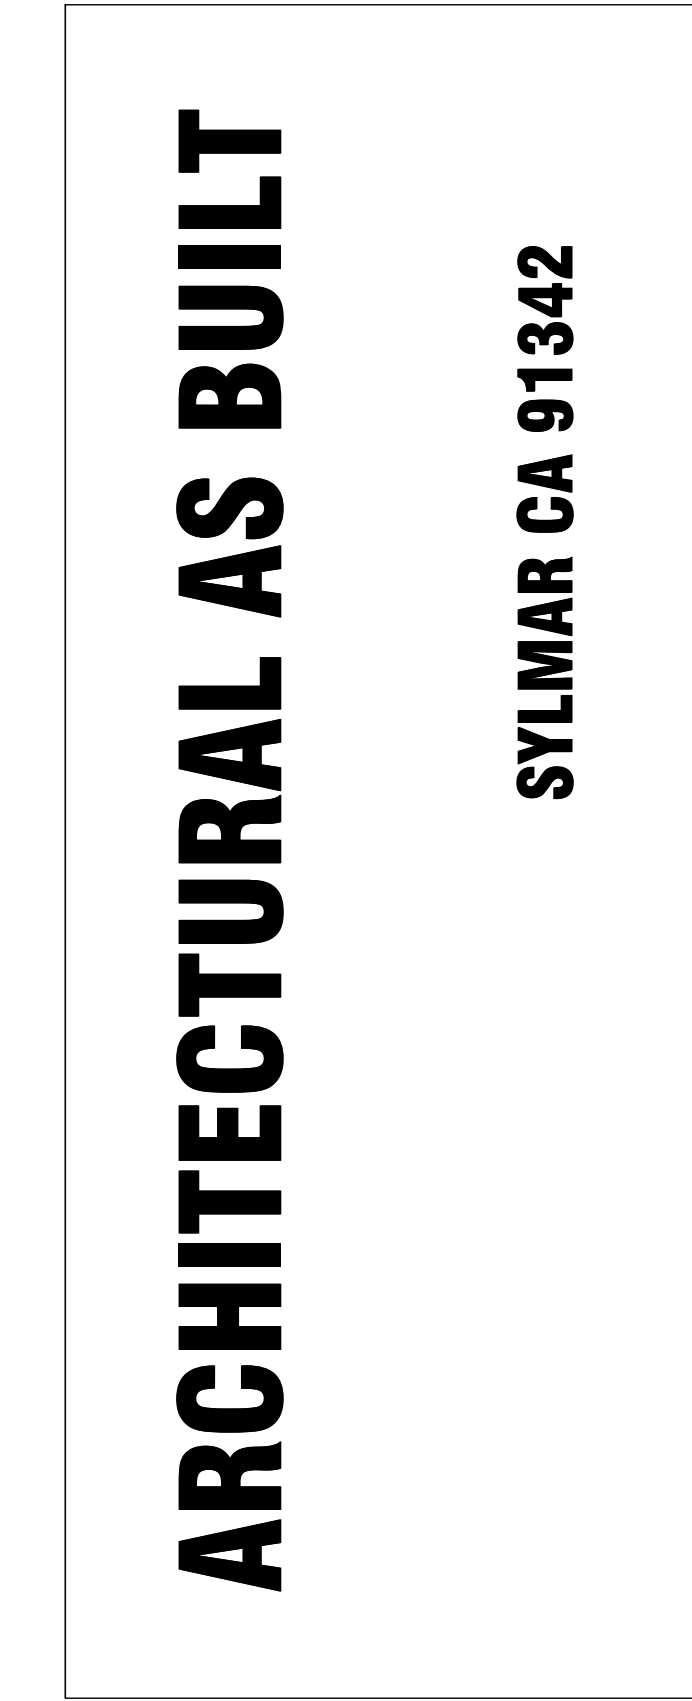

A DIVISION OF:




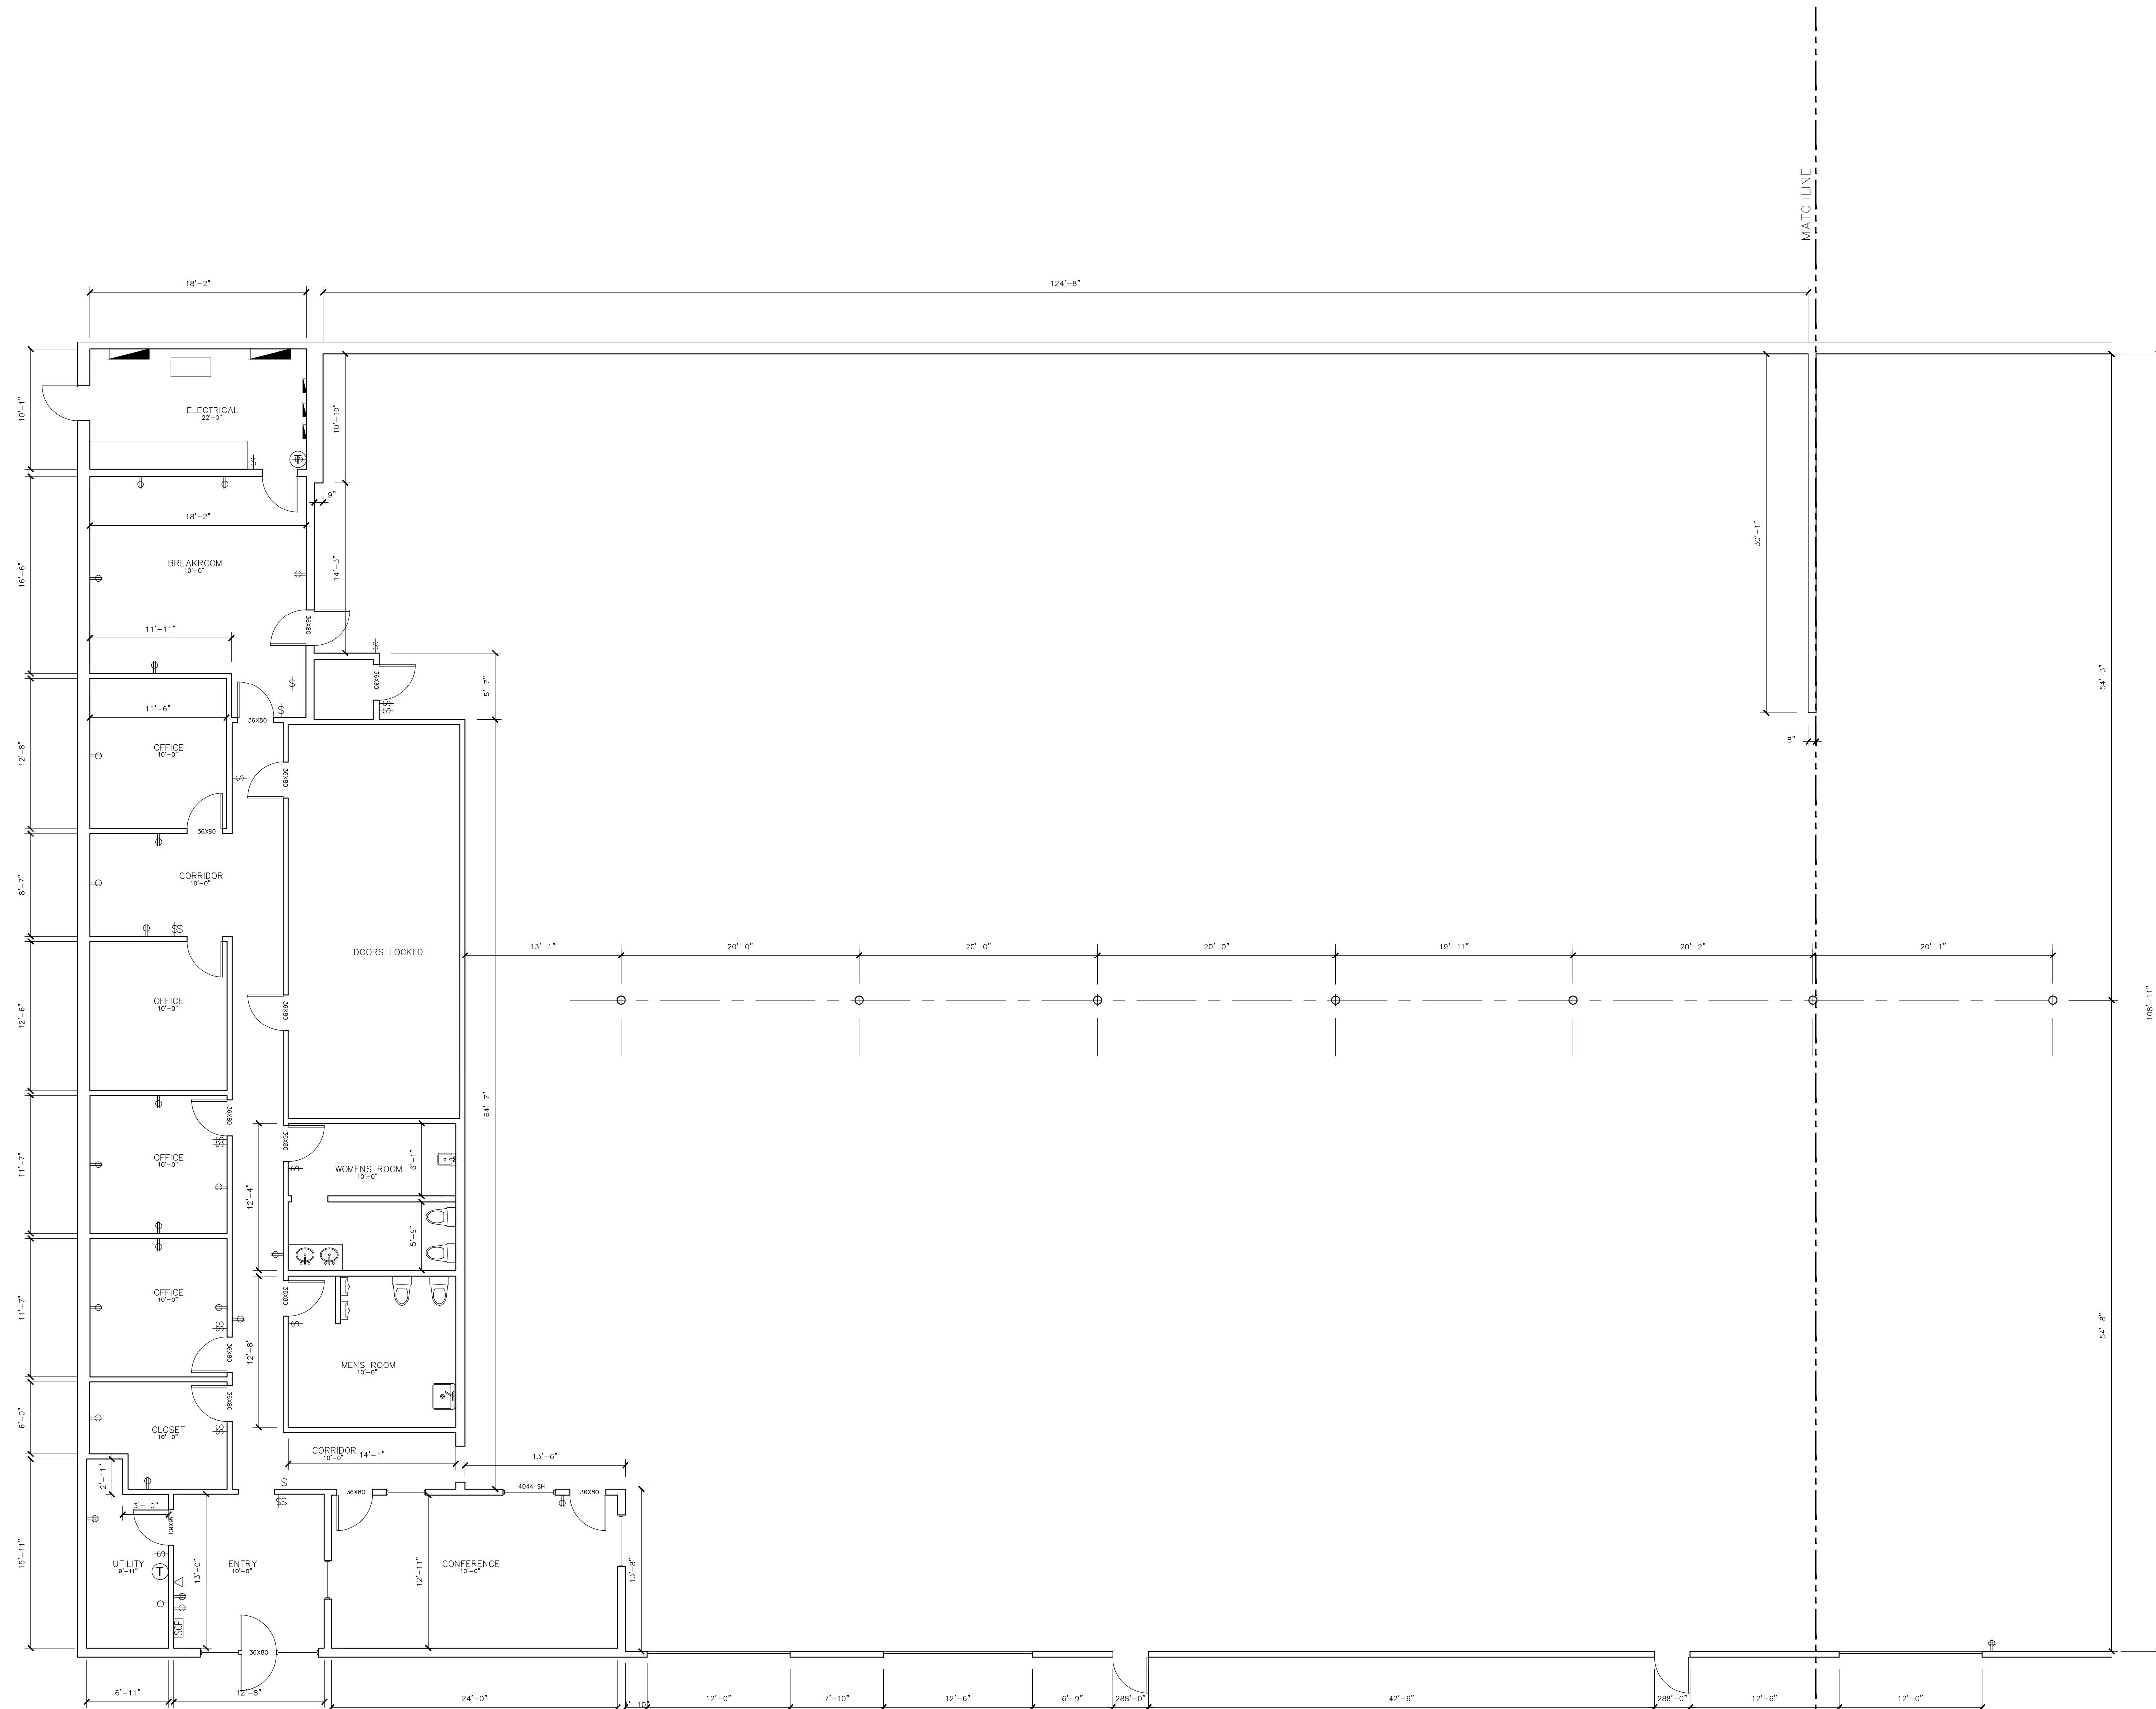
© 2017 AEC CONSULTANTS INC


# ARCHITECTURAL AS BUILT

**SYLMAR CA 91342**

01	100% SUBMISSION	
NO.	ISSUES   REVISIONS	DATE
		SHEET TITLE
HL	PROJECT MANAGER	
HL	PROJECT DIRECTOR	
	PROJECT NUMBER	
1/8"=1'-0"		SCALE
MM	DRAWN BY	
		SHEET NUMBER

**AB-2**

 FLOORPLAN - DIMENSIONED

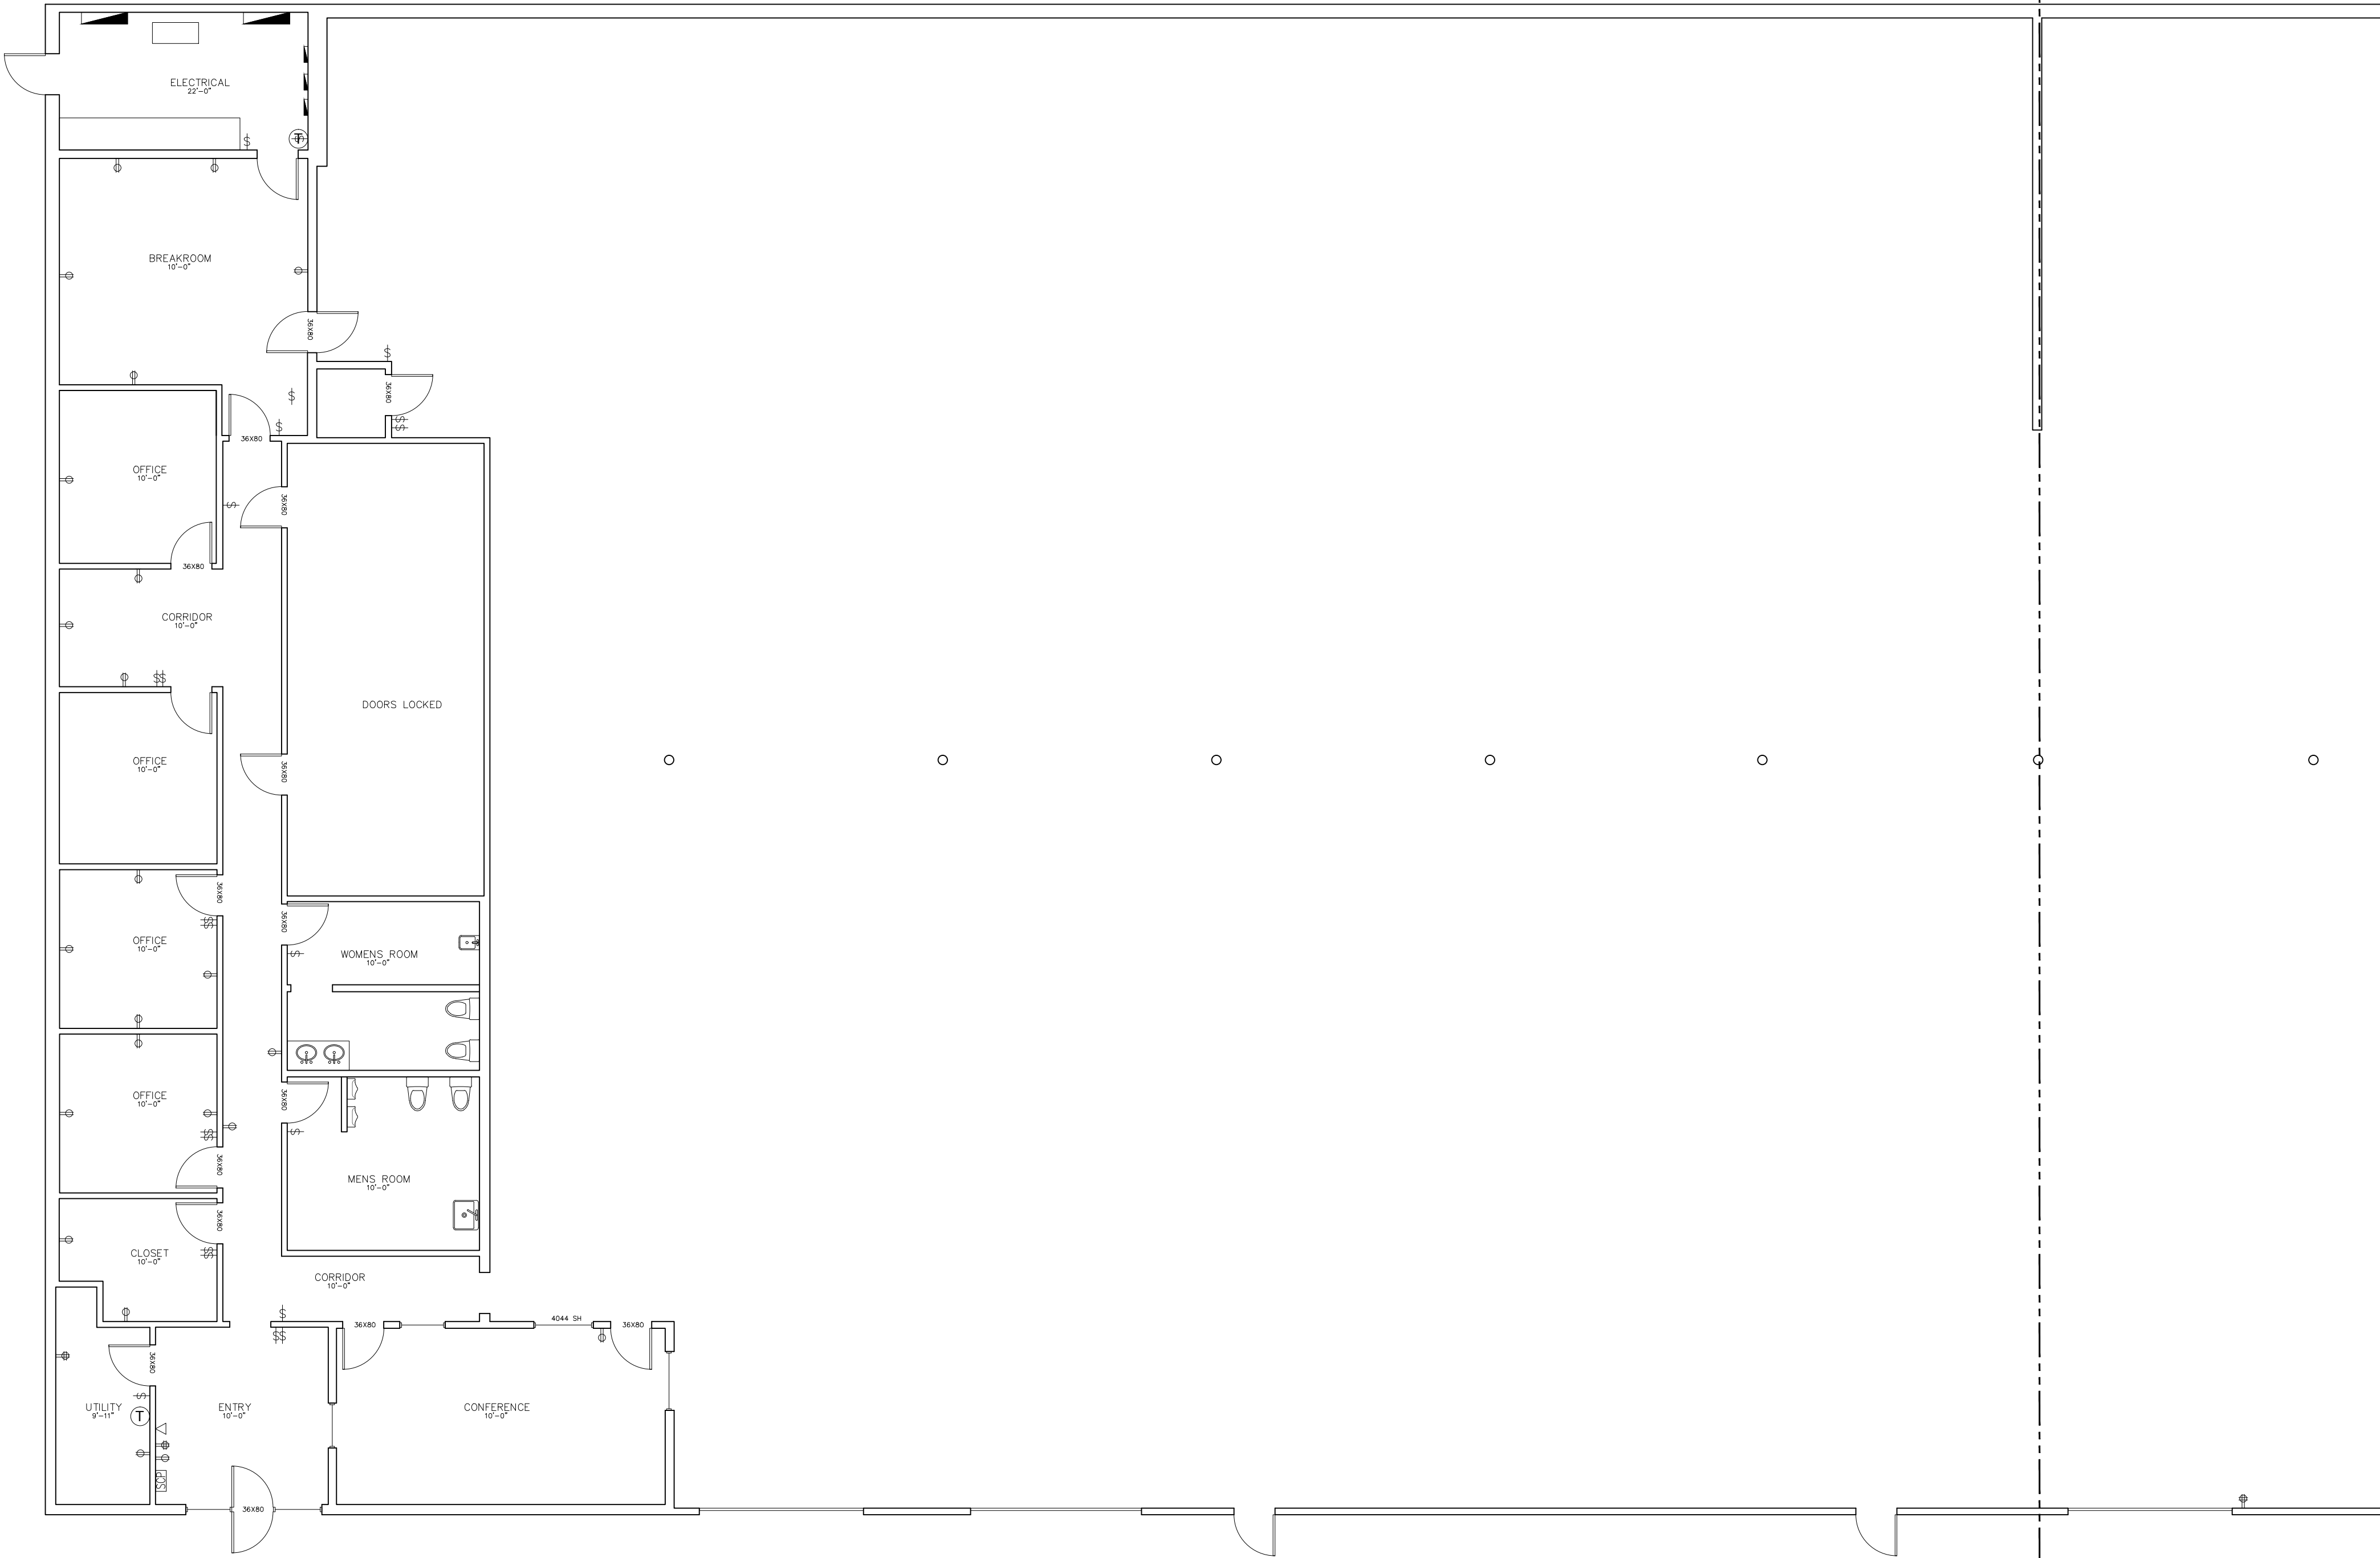

 FLOORPLAN

ARCHITECTURAL AS BUILT


SYLMAR CA 91342

01	100% SUBMISSION	
NO.	ISSUES   REVISIONS	DATE
SHEET TITLE		
HL	PROJECT MANAGER	
HL	PROJECT DIRECTOR	
	PROJECT NUMBER	
1/8"=1'-0"	SCALE	
MM	DRAWN BY	
	SHEET NUMBER	



**SYLMAR CA 91342**
 
# AB-4





# ARCHITECTURAL AS BUILT

SYLMAR CA 91342

01	100% SUBMISSION	
NO.	ISSUES   REVISIONS	DATE
SHEET TITLE		
HL	PROJECT MANAGER	
HL	PROJECT DIRECTOR	
	PROJECT NUMBER	
1/8"=1'-0"	SCALE	
MM	DRAWN BY	
	SHEET NUMBER	

**AB-5**

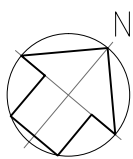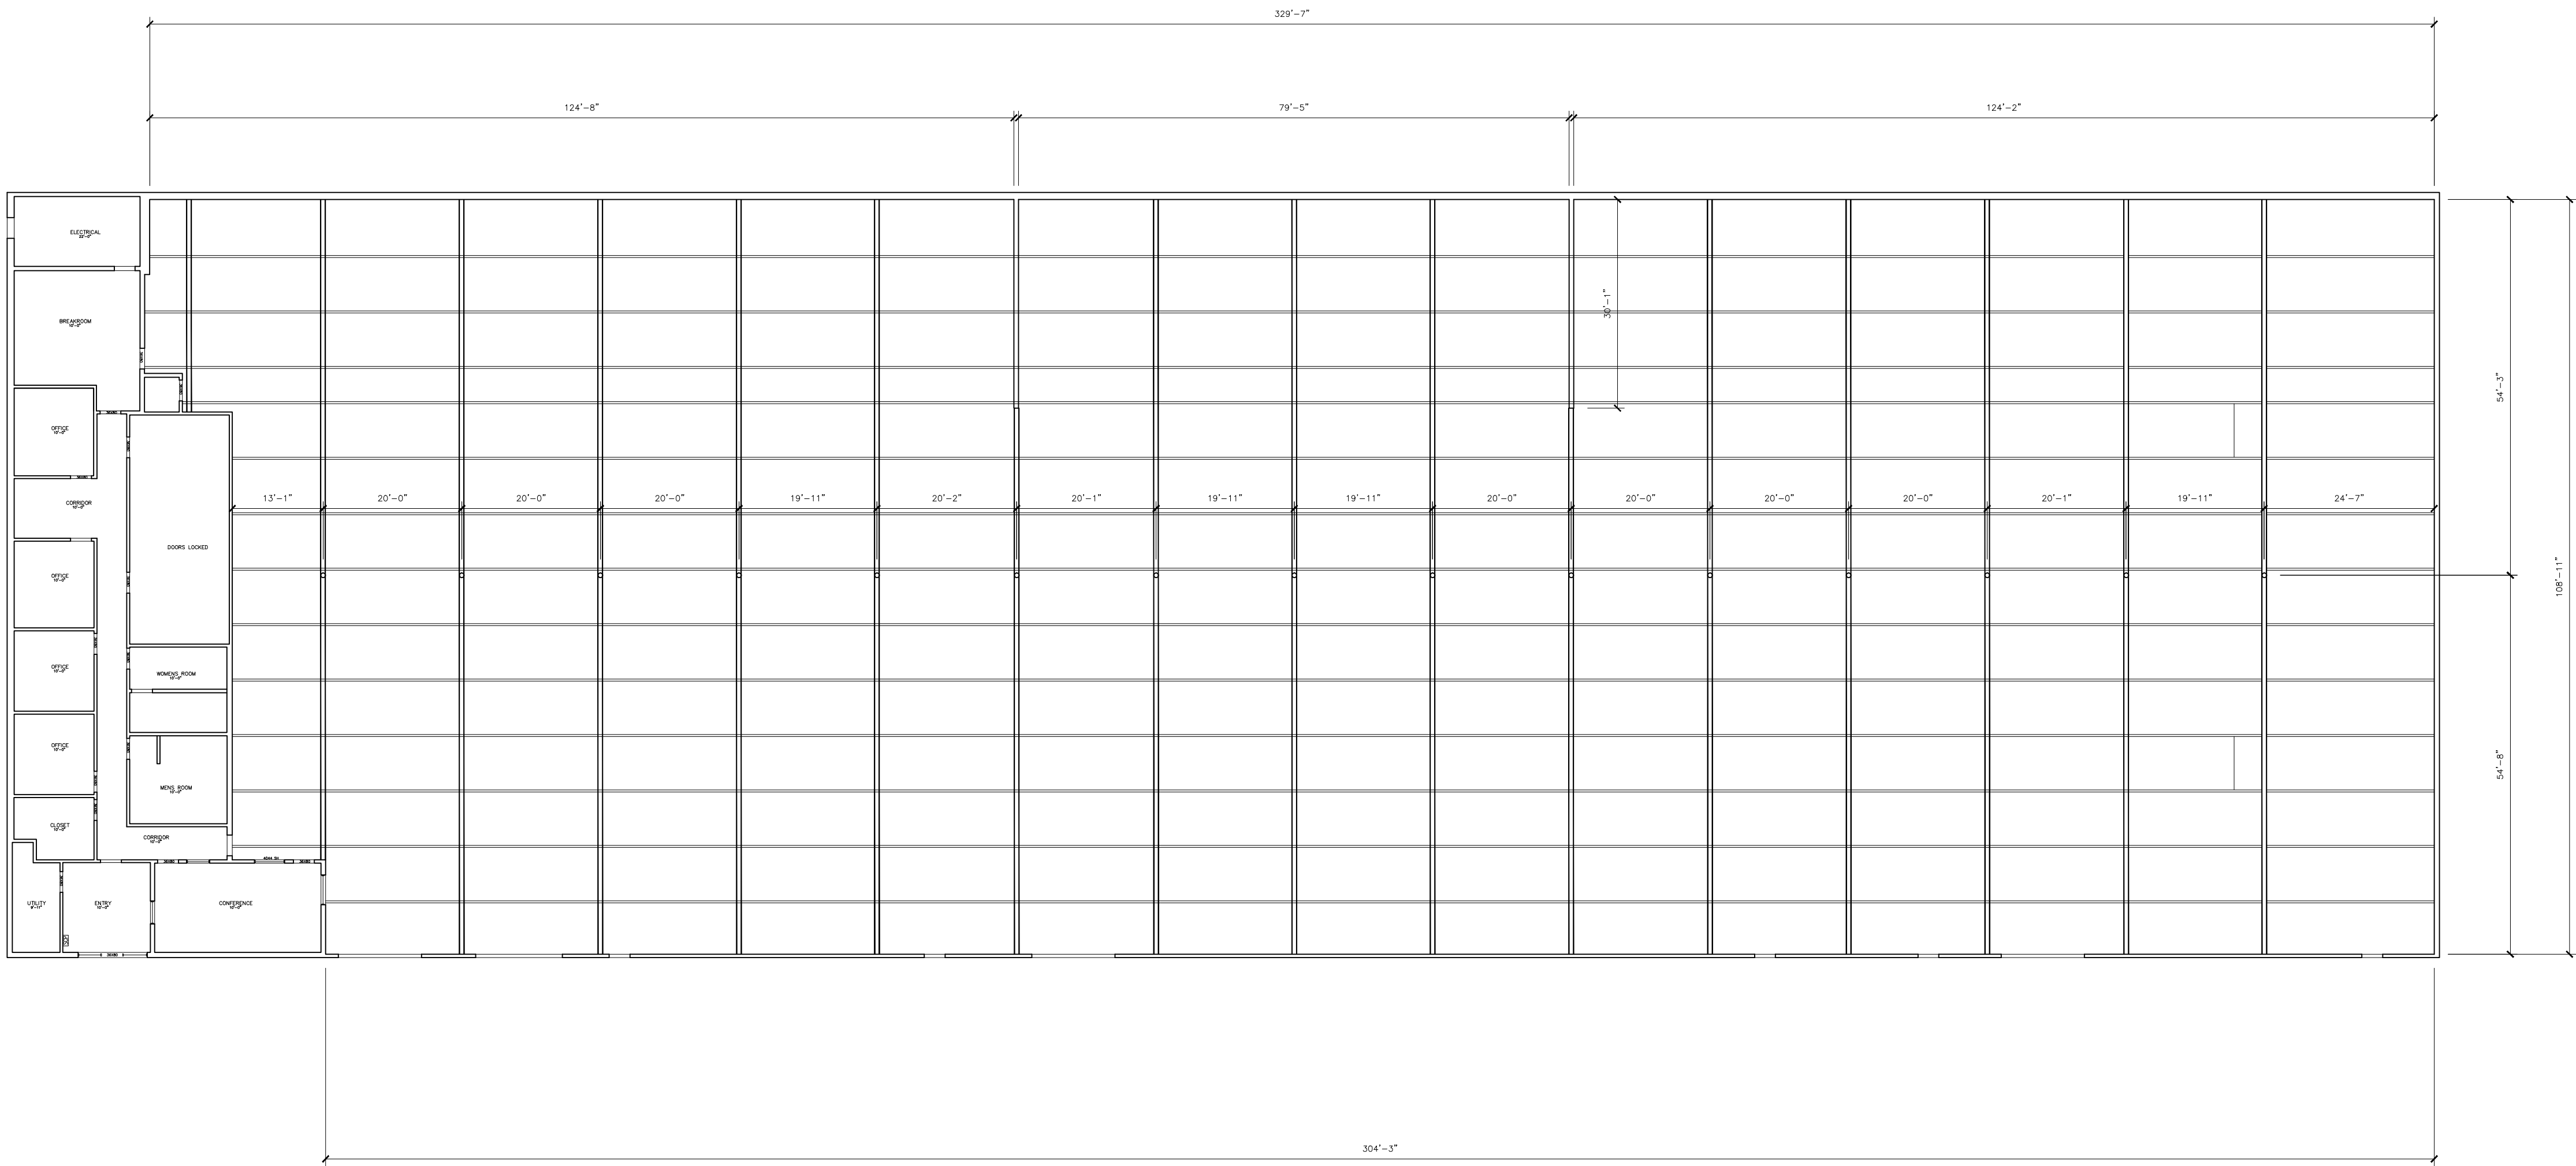

OVERALL CEILING PLAN

ARCHITECTURAL AS BUILT

SYLMAR CA 91342



01	100% SUBMISSION	
NO.	ISSUES   REVISIONS	DATE

SHEET TITLE

HL	PROJECT MANAGER
HL	PROJECT DIRECTOR
	PROJECT NUMBER
1/16"=1'-0"	SCALE
MM	DRAWN BY
	SHEET NUMBER

AB-6

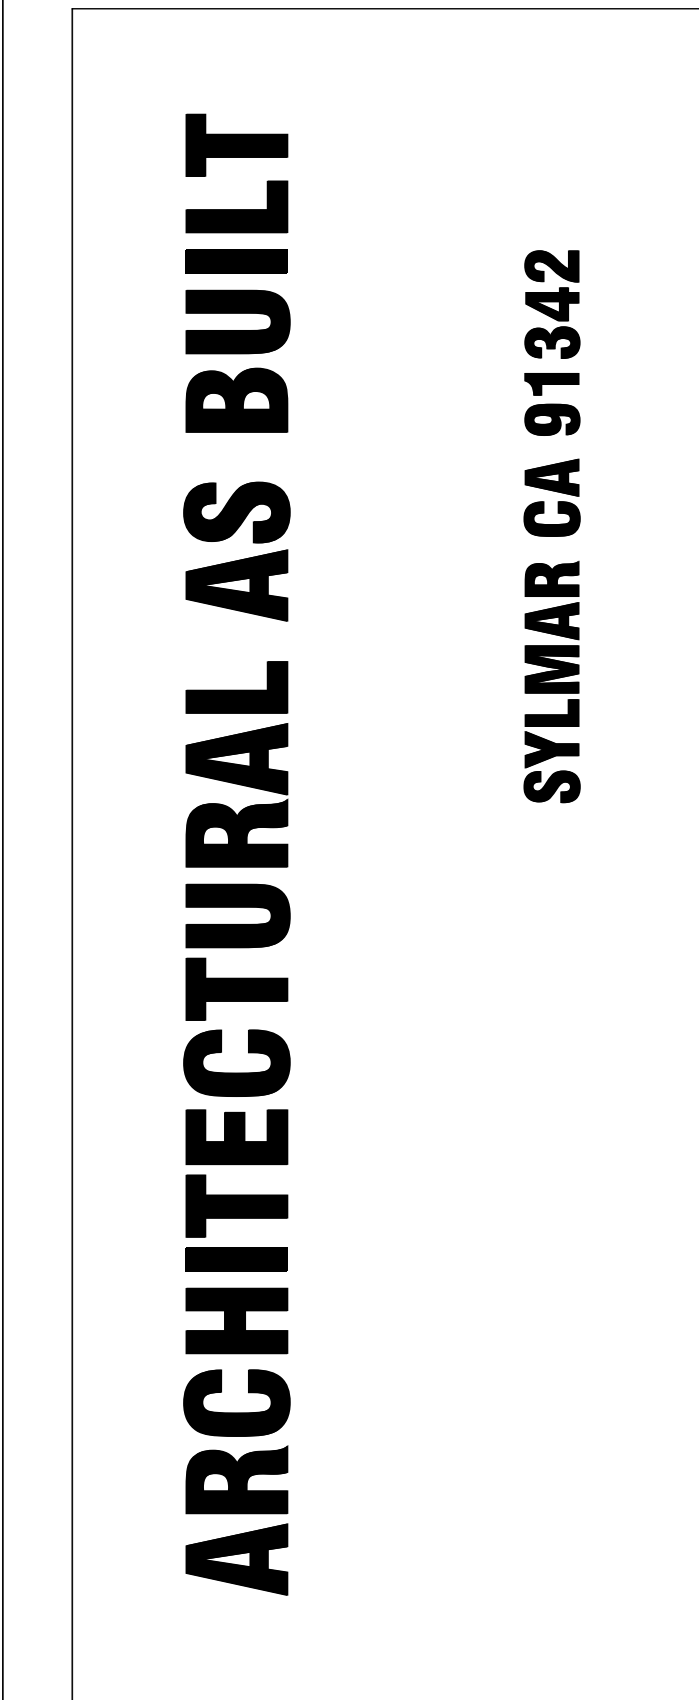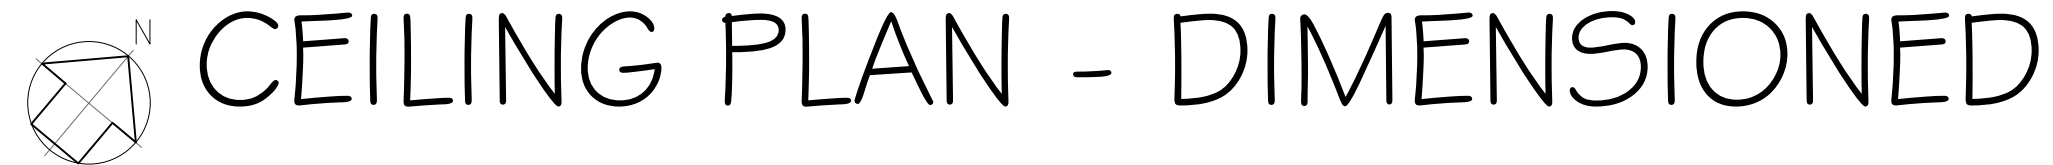

AB-7



A DIVISION OF:



© 2017 AEC CONSULTANTS INC

# ARCHITECTURAL AS BUILT

**SYLMAR CA 91342**

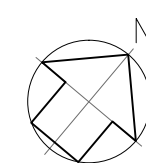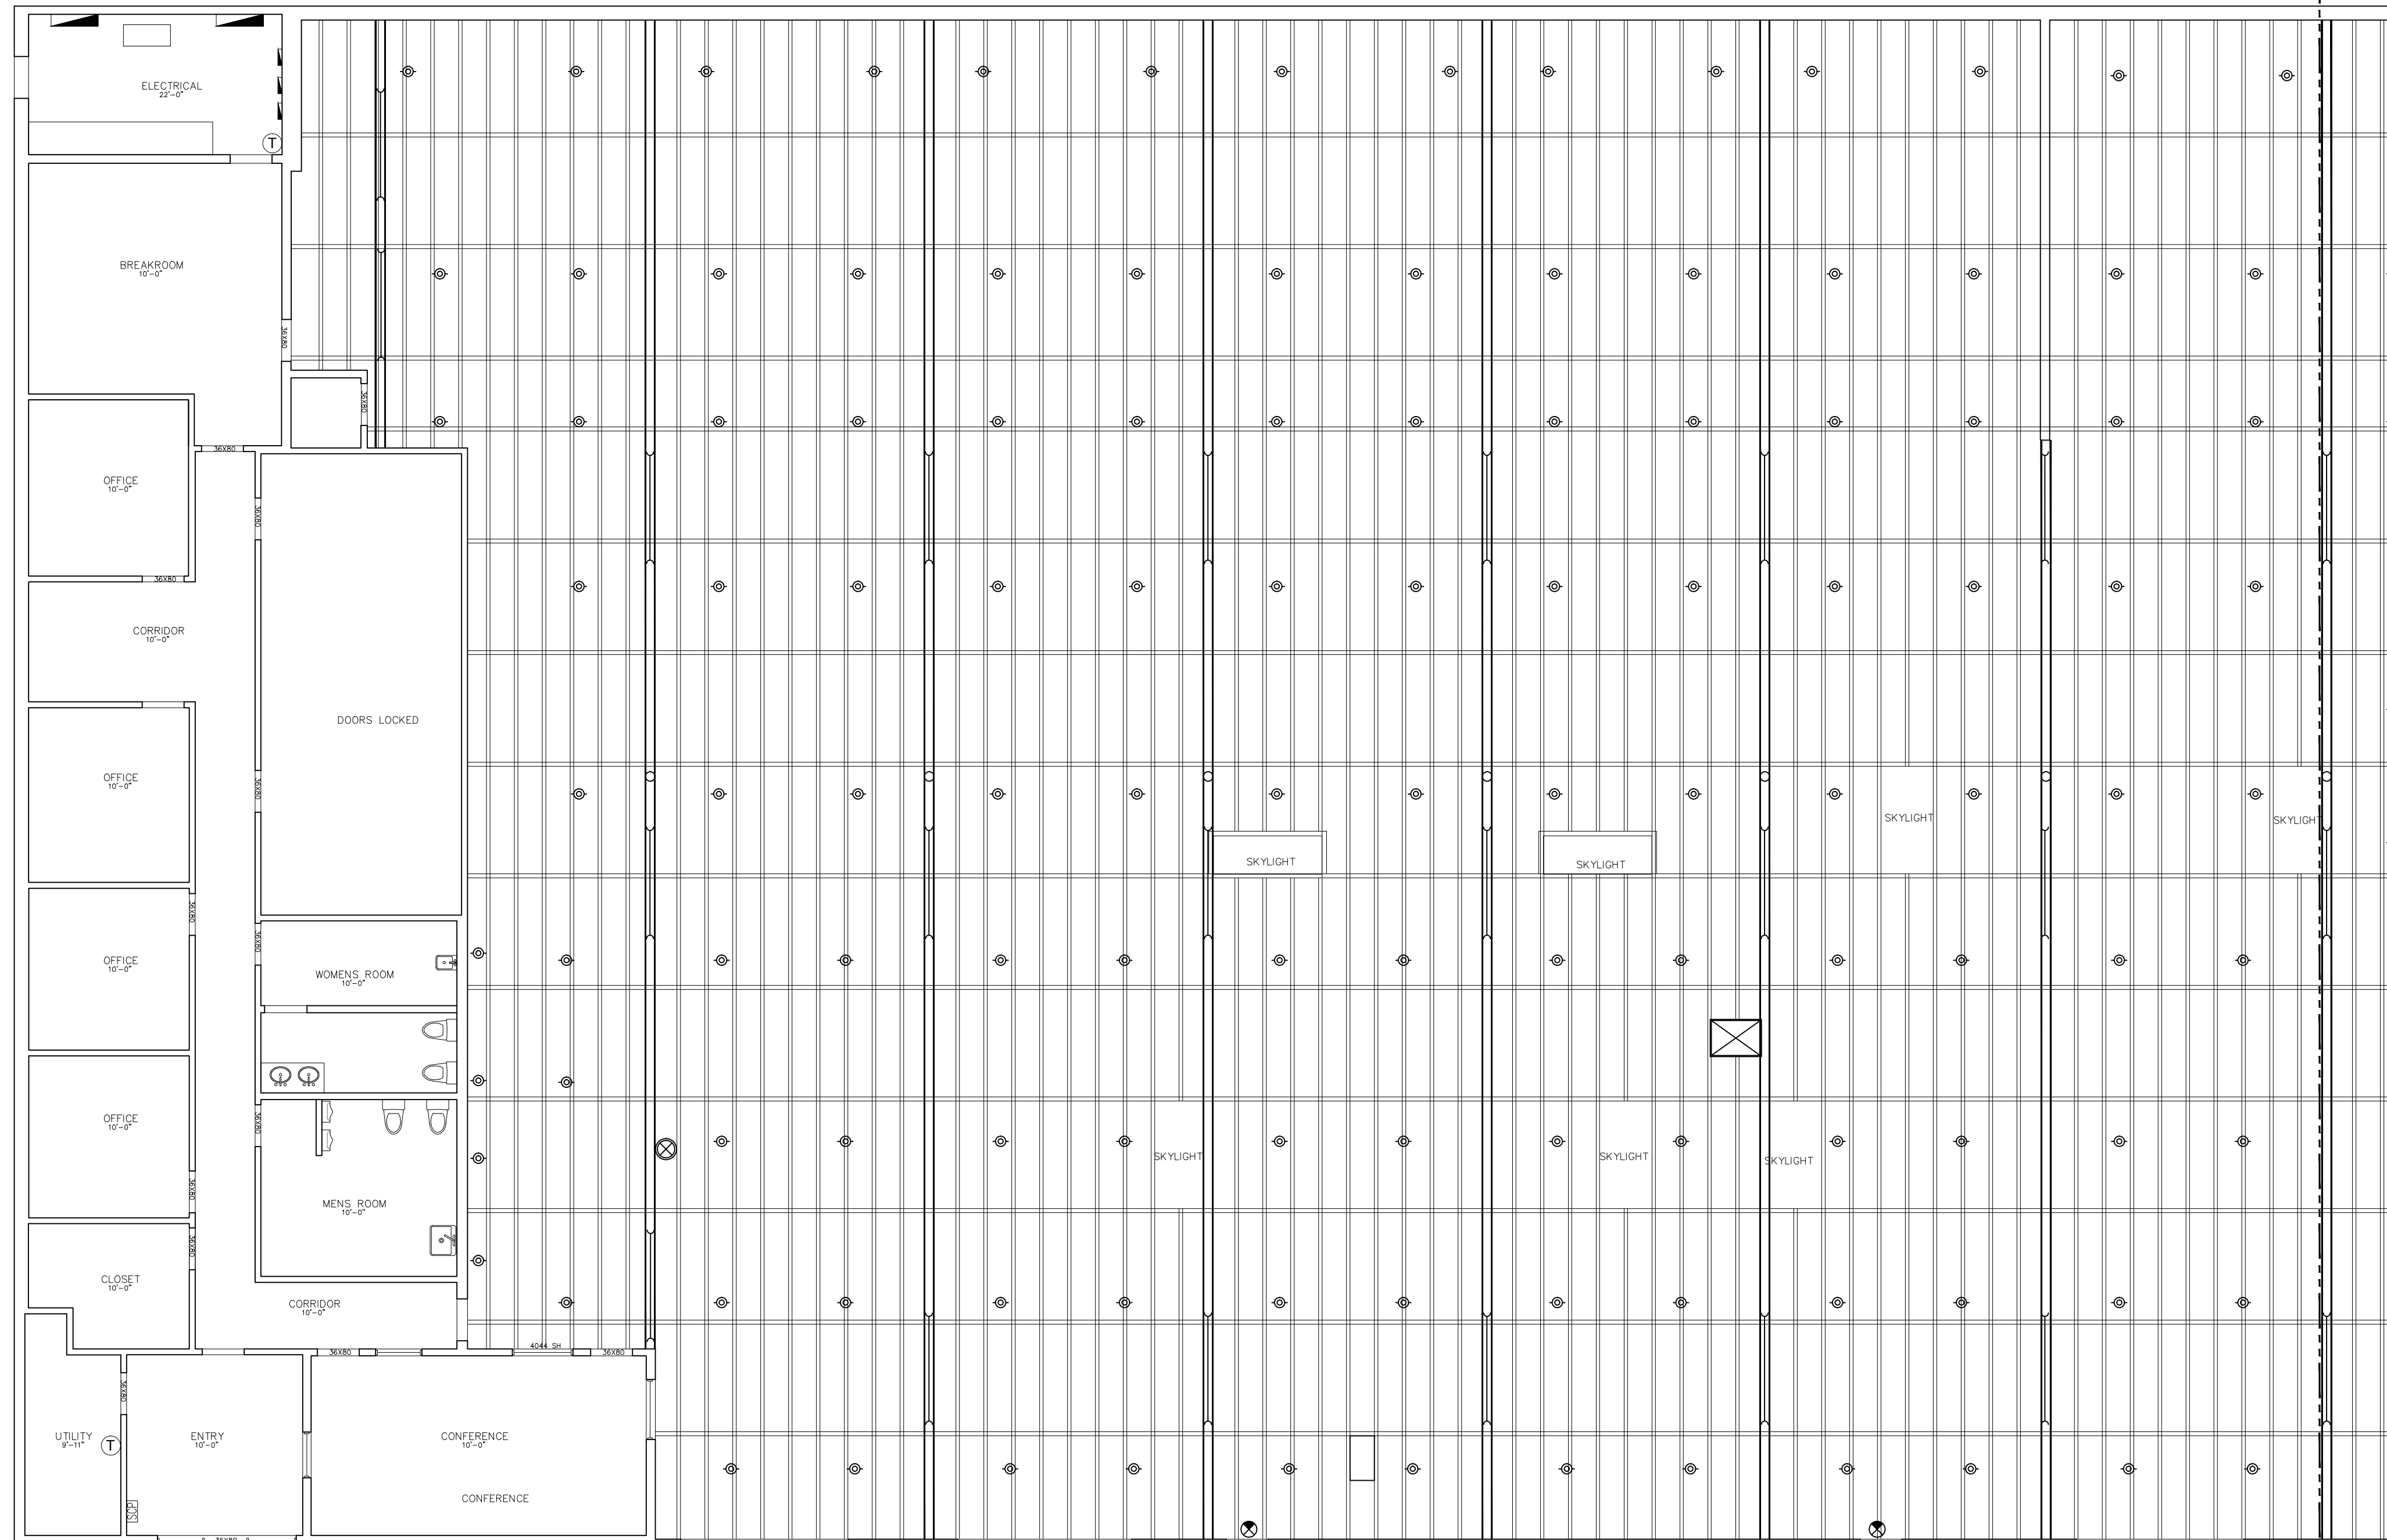

# CEILING PLAN

01	100% SUBMISSION	
NO.	ISSUES   REVISIONS	DATE
		SHEET TITLE
HL	PROJECT MANAGER	
HL	PROJECT DIRECTOR	
		PROJECT NUMBER
1/8"=1'-0"		SCALE
MM	DRAWN BY	
		SHEET NUMBER

# AB-8


**ARCHITECTURAL AS BUILT**


**SYLMAR CA 91342**

01	100% SUBMISSION	
NO.	ISSUES   REVISIONS	DATE
		SHEET TITLE

HL	PROJECT MANAGER
HL	PROJECT DIRECTOR
	PROJECT NUMBER
1/8"=1'-0"	SCALE
MM	DRAWN BY
	SHEET NUMBER

**AB-9**

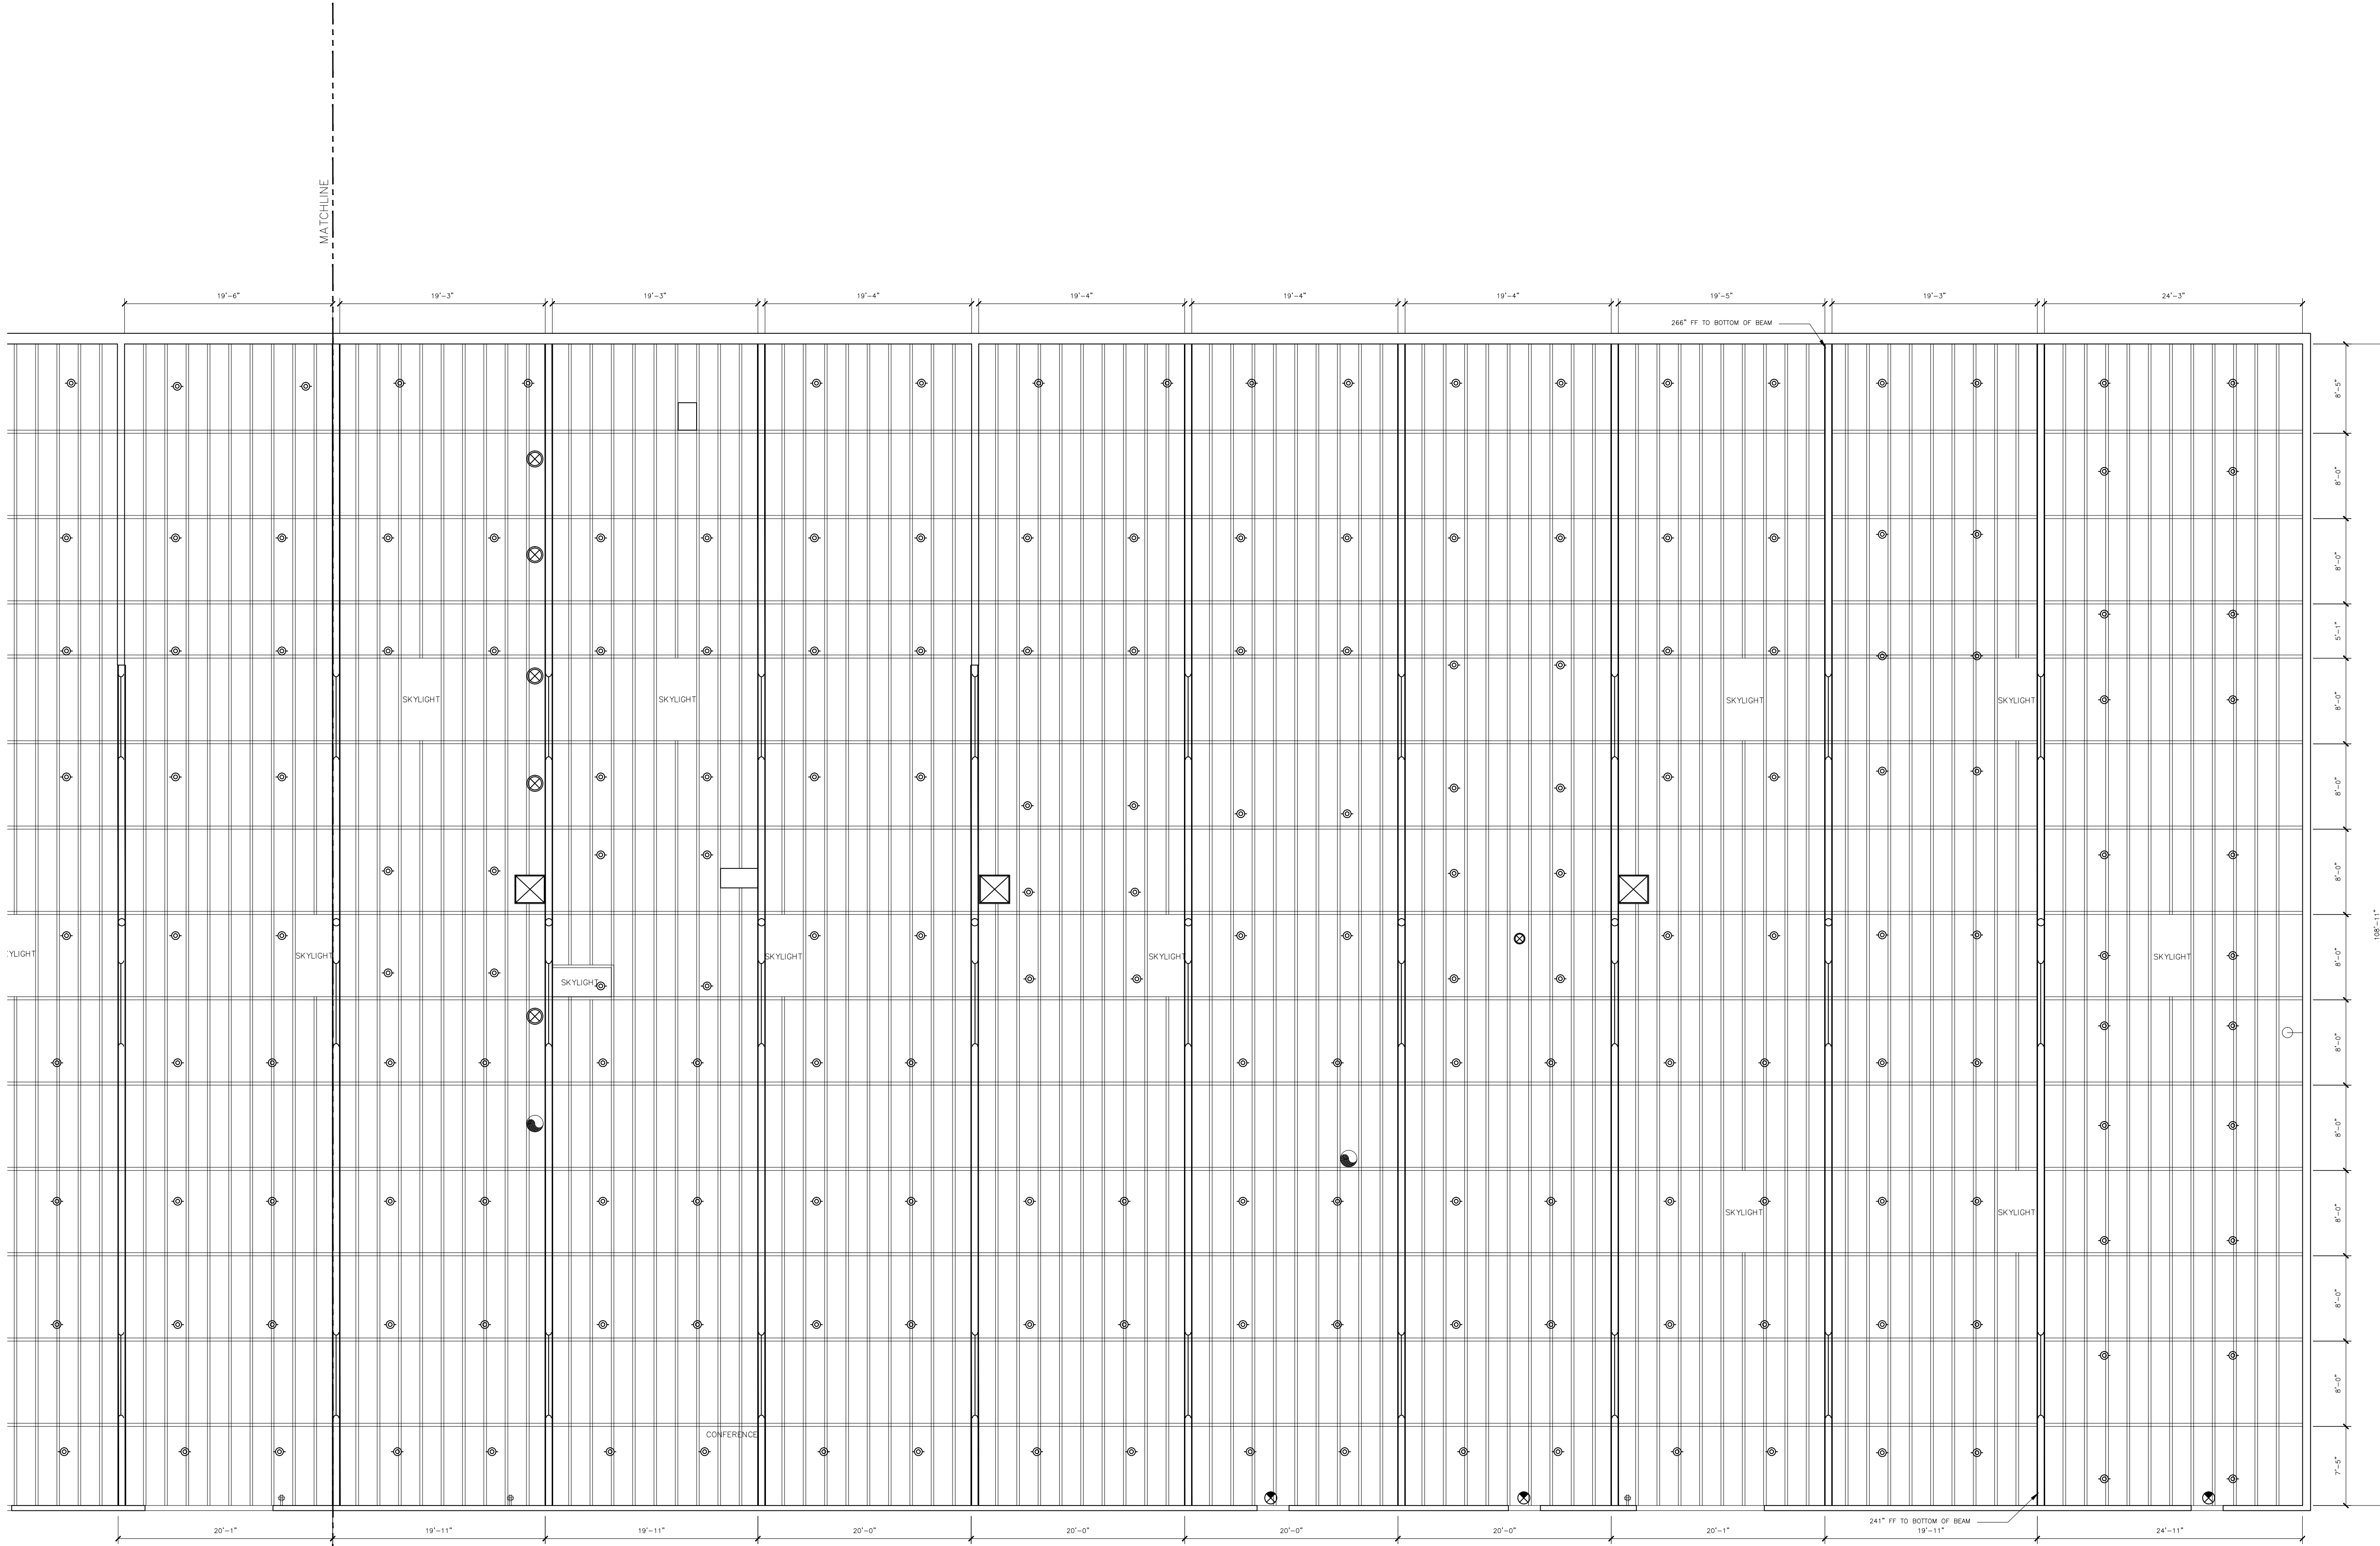

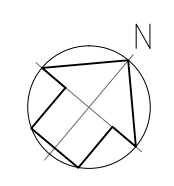 **CEILING PLAN - DIMENSIONED**



ARCHITECTURAL AS BUILT



SYLMAR CA 91342

01	100% SUBMISSION	
NO.	ISSUES   REVISIONS	DATE

SHEET TITLE

HL	PROJECT MANAGER
HL	PROJECT DIRECTOR
	PROJECT NUMBER
1/8"=1'-0"	SCALE
MM	DRAWN BY
	SHEET NUMBER

AB-10

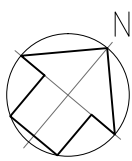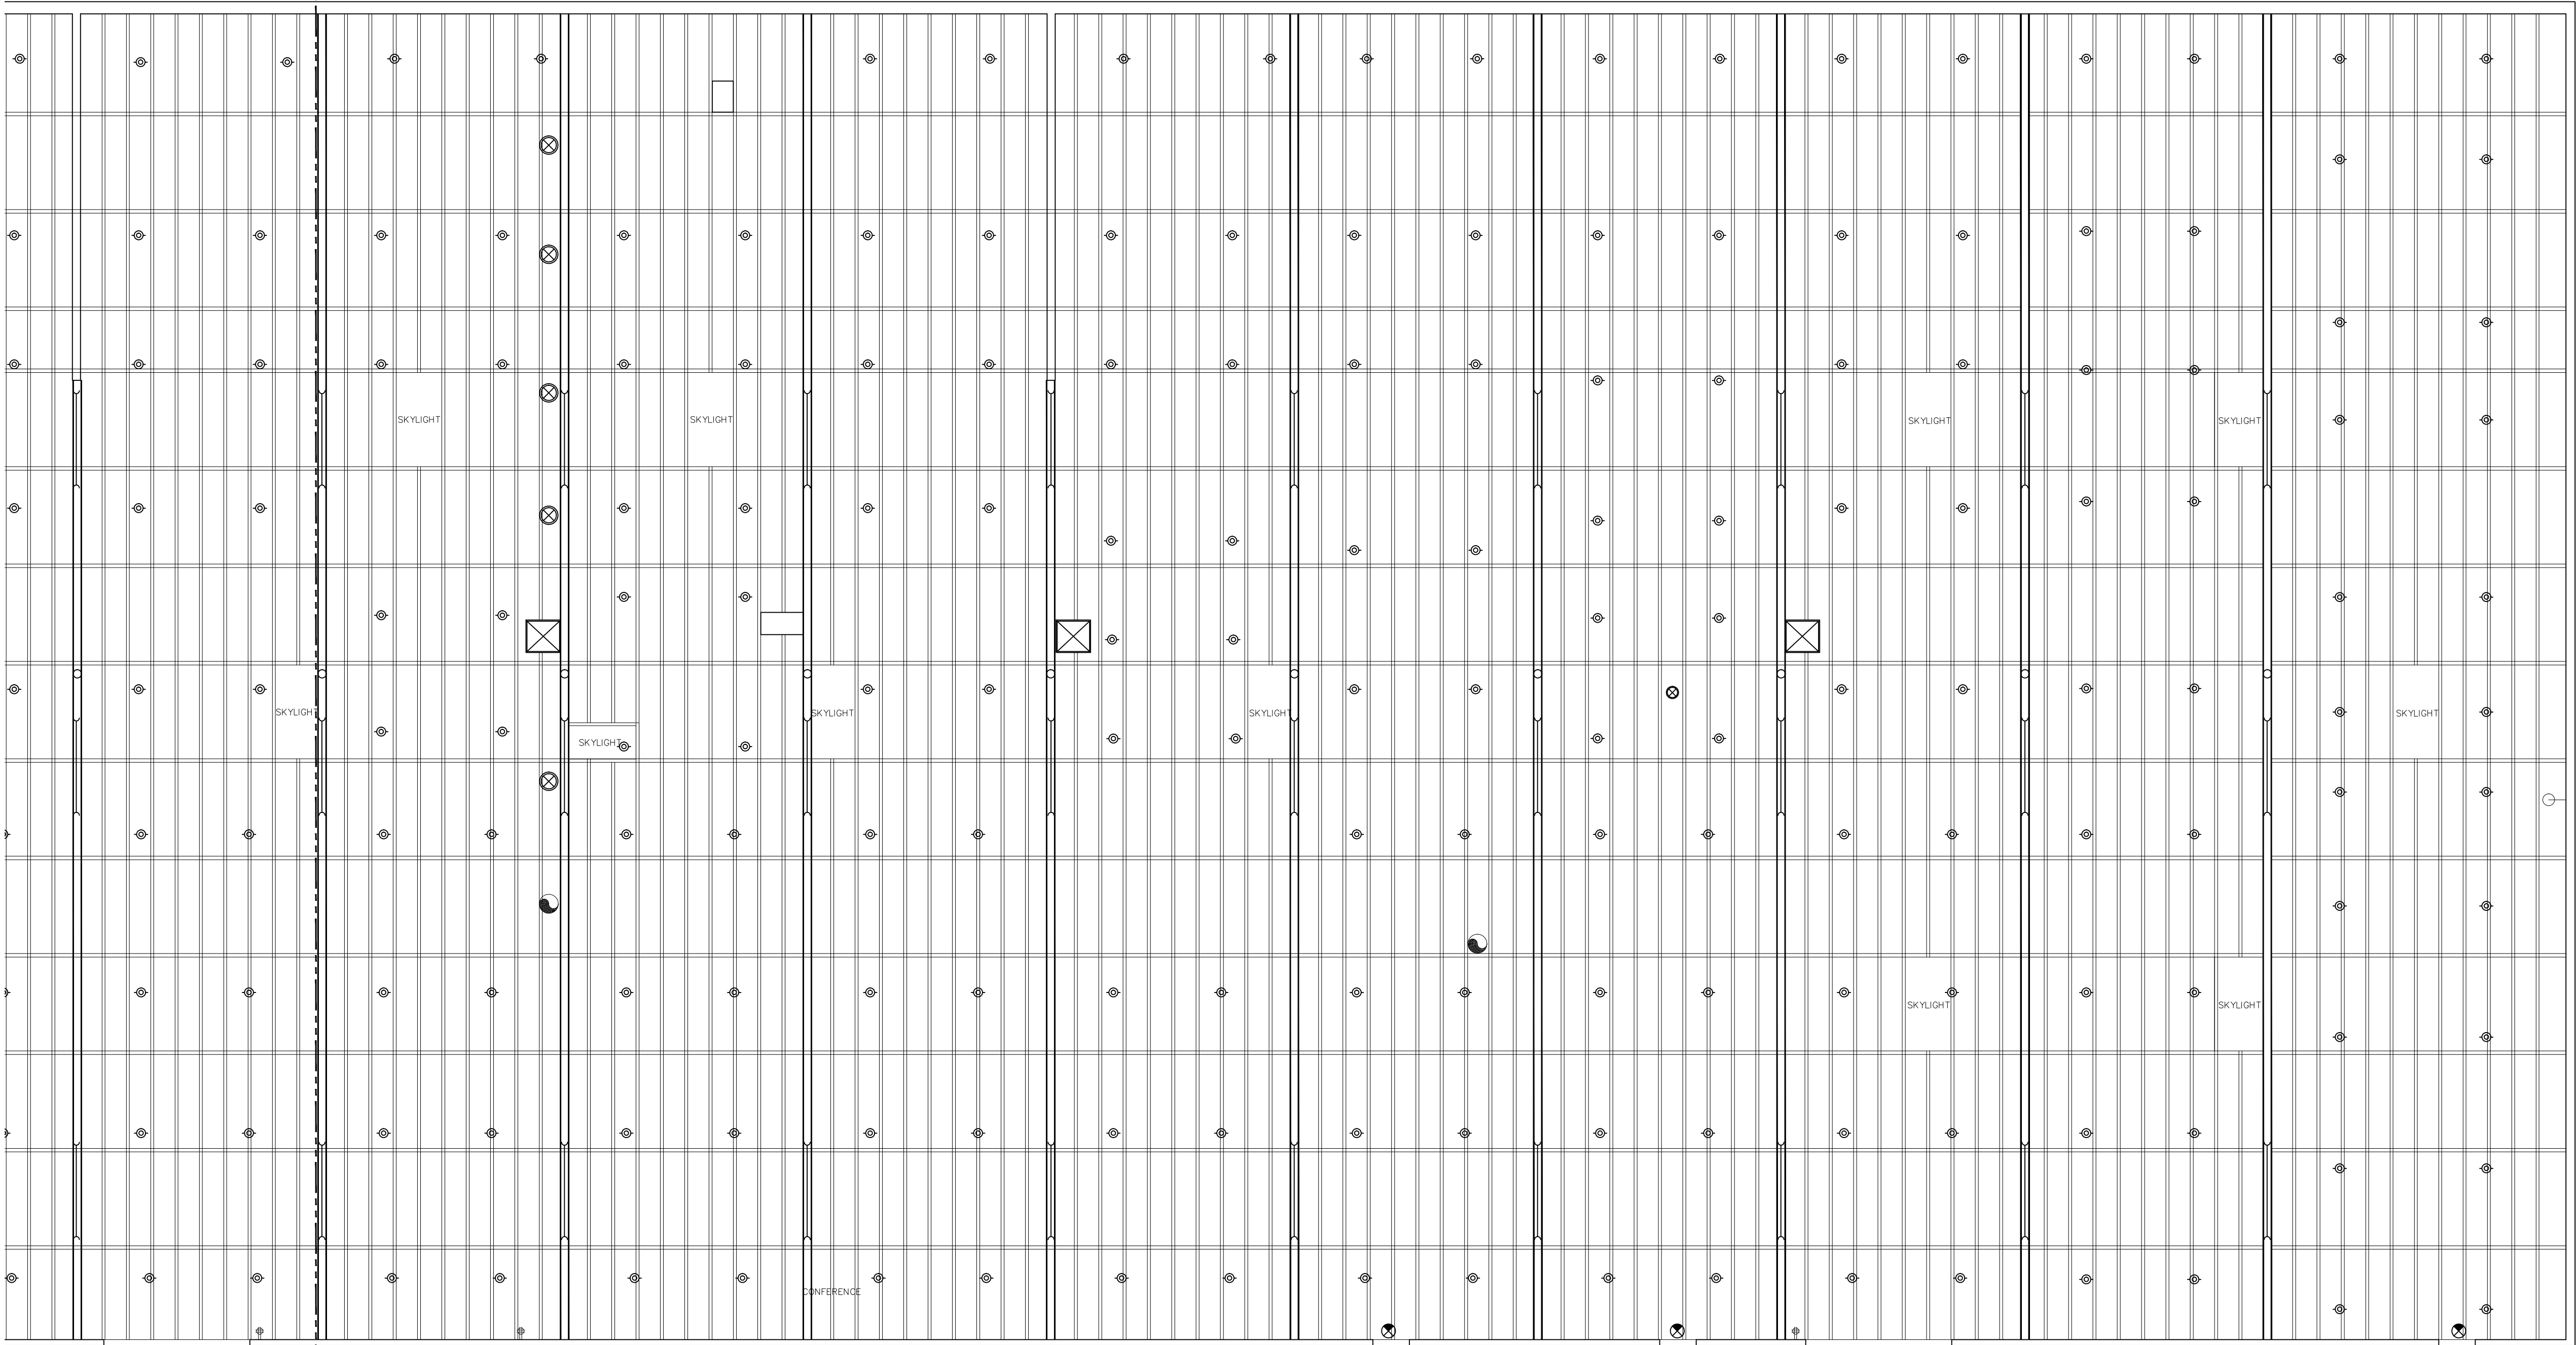

CEILING PLAN