

AS-BUILT DOCUMENTATION


Ocala, FL 34470



100% SUBMITTAL

DRAWING INDEX

- C-1 COVER SHEET | DRAWING INDEX
- SL SYMBOLS LEGEND
- AB-1 OVERALL FLOOR PLAN
- AB-2 AREA "A" FLOOR PLAN $\frac{3}{32}$ "
- AB-3 AREA "B" FLOOR PLAN $\frac{3}{32}$ "
- AB-4 AREA "C" FLOOR PLAN $\frac{3}{32}$ "
- AB-5 AREA "D" FLOOR PLAN $\frac{3}{32}$ "

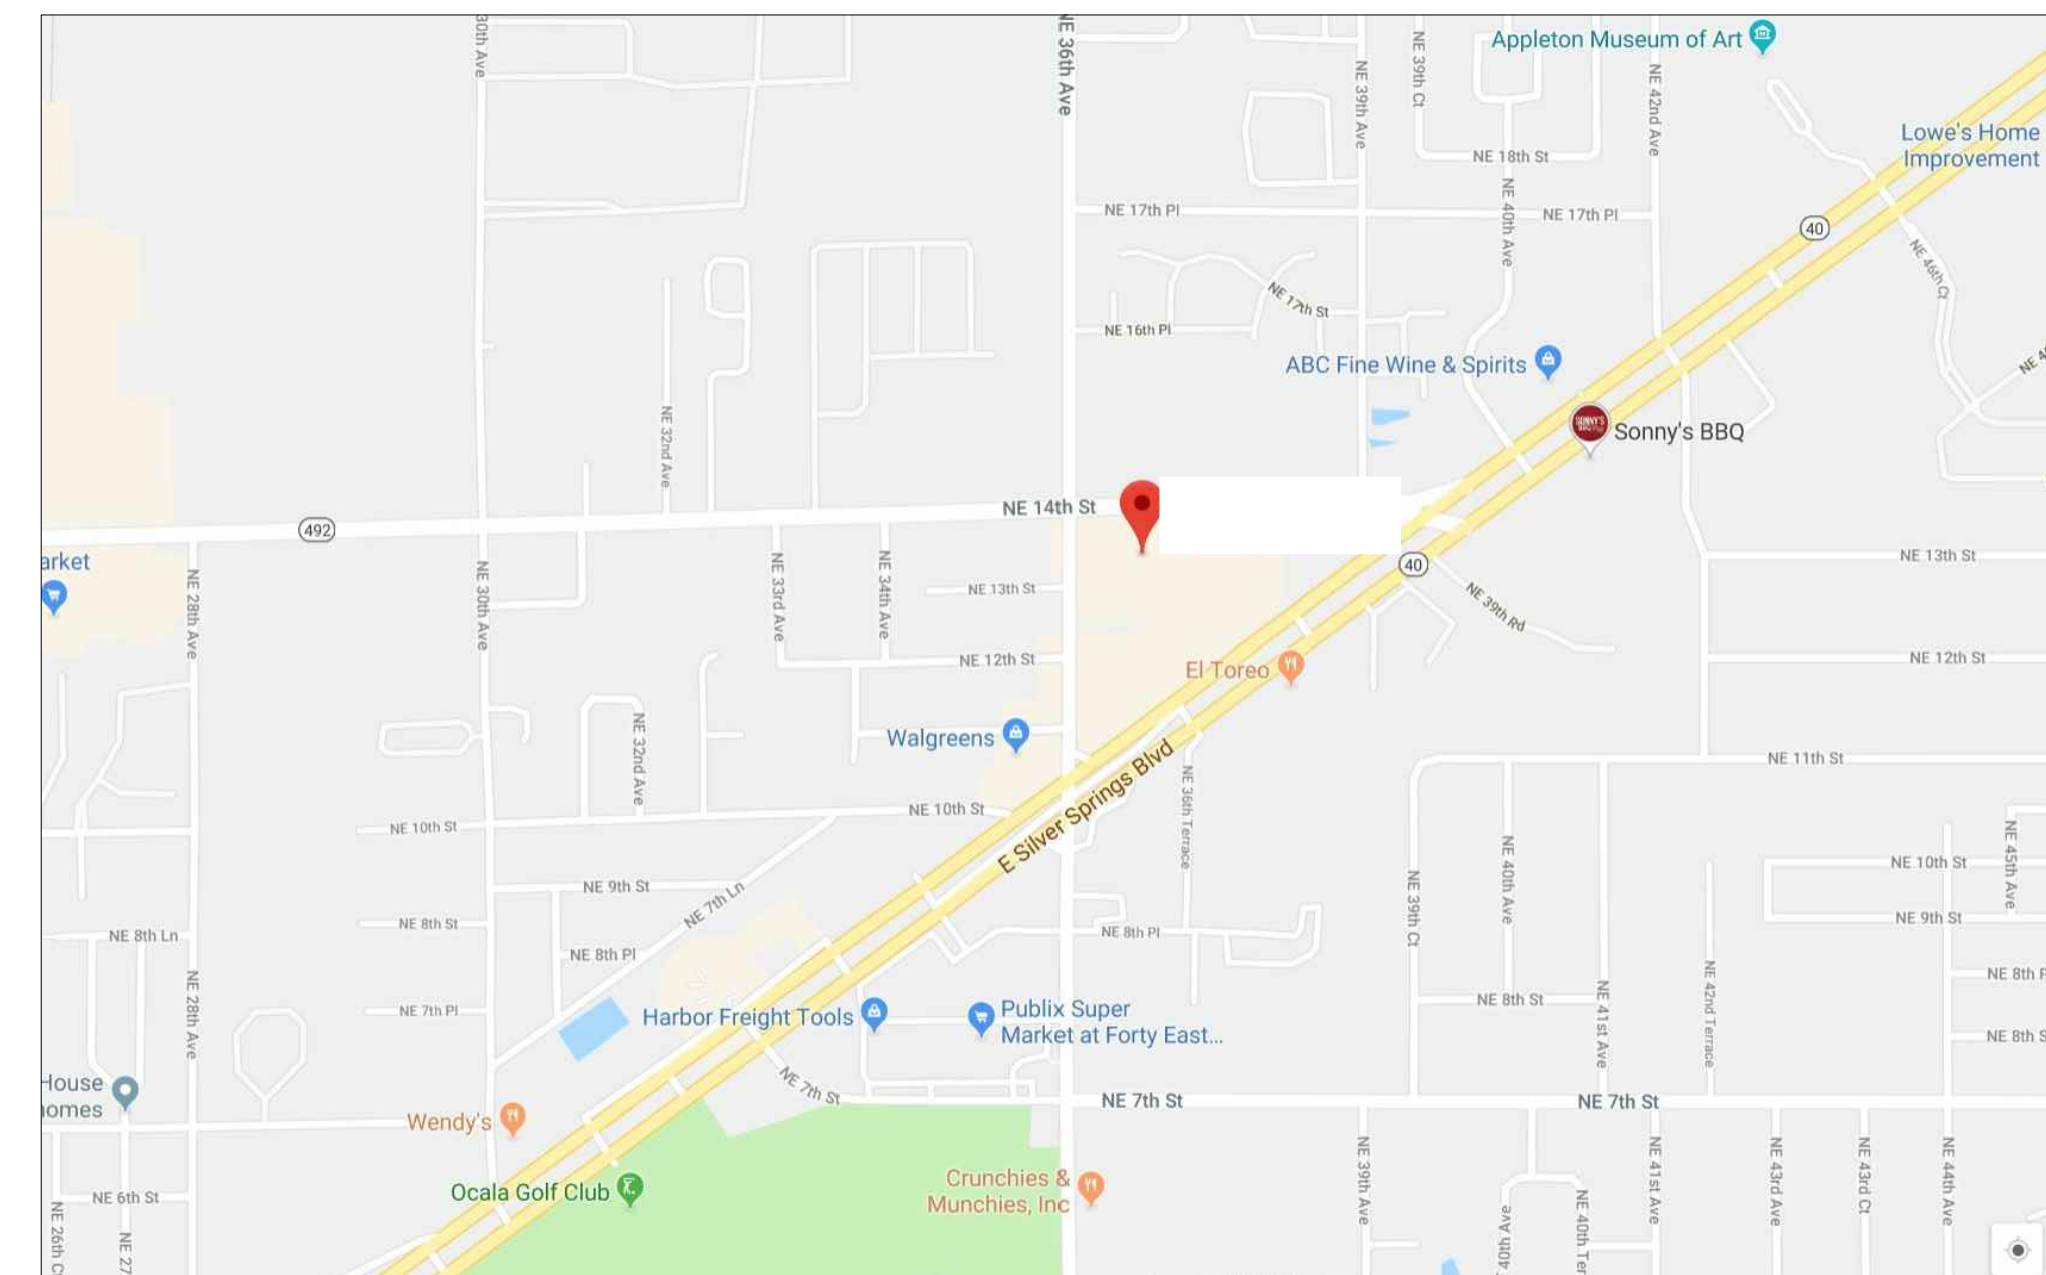

VICINITY MAP
NTS

AREA DATA	
FIRST FLOOR	112,809 S.F. ±
SECOND FLOOR	NOT INCLUDED
GATED FENCED GARDEN AREA	NOT INCLUDED
COVERED ENTRIES	NOT INCLUDED
COVERED LOADING AREAS	NOT INCLUDED
GRAND TOTAL	NOT INCLUDED

AS BUILT
PROFESSIONALS
www.asbuiltprofessionals.com
A DIVISION OF:

AEC
CONSULTANTS
INC
844.272.8458
844.ASBUILT

© 2019 AEC CONSULTANTS INC.

ARCHITECTURAL AS BUILT

Ocala, FL 34470

01	100% SUBMISSION	SEE COVER SHEET
NO.	ISSUES REVISIONS	DATE
		SHEET TITLE

COVER SHEET	
HL	PROJECT MANAGER
HL	PROJECT DIRECTOR
012318-1	PROJECT NUMBER
	SCALE
CL	DRAWN BY
C-1	
	SHEET NUMBER

SYMBOLS LEGEND

RCP

- EXHAUST VENT
- CEILING MOUNTED LIGHT FIXTURE
- CEILING MOUNTED DIRECTIONAL LIGHT
- RECESSED CAN LIGHT
- EYEBALL OR SMALL CAN LIGHT
- PENDANT LIGHT
- INDIVIDUAL FLUOR. LAY-IN FIXTURE 4 BULB
- INDIVIDUAL FLUOR. HANGING FIXTURE 2 BULB
- INDIVIDUAL FLUOR. FLUSH MOUNT FIXTURE 4 BULB
- CAMERA
- MOTION DET.
- SUPPLY VENT
- SUPPLY VENT
- RETURN VENT
- RETURN VENT
- SPEAKER

- TRACK LIGHT OR VANITY LIGHT
- WALL-MOUNTED LIGHT FIXTURE
- EMERGENCY EXIT SIGN
- EMERGENCY EXIT LIGHT
- EMERGENCY EXIT LIGHT W/ SIGN
- LIGHTED STAIR SIGN
- FLOOD LIGHT
- PHOTO CELL
- CEILING FAN
- CEILING FAN W/ LIGHT KIT
- 7-2-6** CEILING HEIGHT AND TRIM 7'-2" ABOVE FLOOR BELOW WITH 6" CROWN MOULDING. NOTE: ALL CEILINGS NOT LABELED ARE PLASTER. CEILINGS SHOWN WITH A GRID ARE LAY IN ACOUSTICAL TILE..
- JUNCTION BOX

ELECTRIC

- DATA OUTLET
- TELEPHONE JACK
- ELECTRIC SWITCH
- CABLE TELEVISION OUTLET
- DUPLEX RECEPTACLE OUTLET
- SPECIAL PURPOSE CONNECTION OR OUTLET
- QUADRUPLEX RECEPTACLE OUTLET
- FLOOR DUPLEX RECEPTACLE OUTLET
- ELECTRIC PANEL
- ELECTRIC METER
- BUTTON SWITCH
- DISCONNECT SWITCH
- GROUND/FLOOR LIGHT
- KEY PAD

FIRE PROTECTION

- FIRE EXTINGUISHER
- FIRE PULL
- FIRE ALARM (HORN/SRTO)
- SMOKE DETECTOR
- SMOKE ALARM SPEAKER
- SPRINKLER HEAD CEILING MOUNT
- SPRINKLER HEAD WALL MOUNT

MEP

- THERMOSTAT
- FLOOR DRAIN
- VALVE
- HOSE BIB
- WATER SUPPLY
- SUSPENDED GAS HEATER

MISC

- BOLLARD
- SPOT ELEVATION

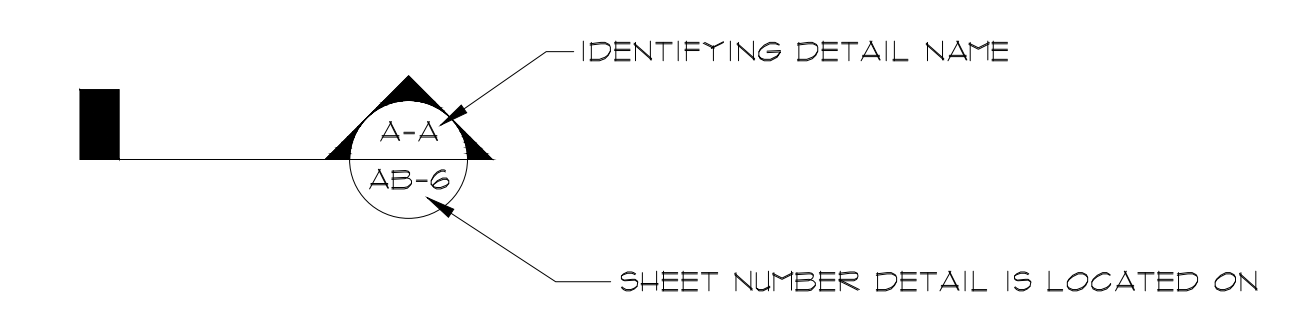
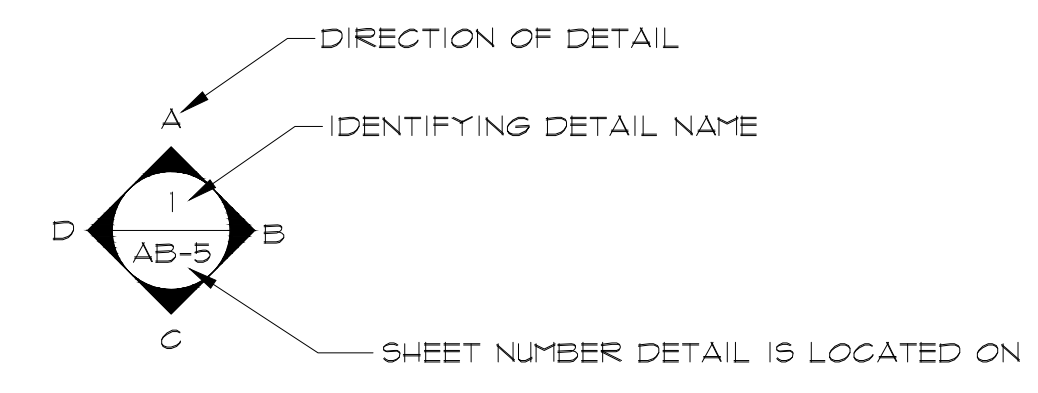


PHOTO DOCUMENTATION LEGEND

INDICATES LOCATION OF CAMERA

INDICATES DIRECTION OF CAMERA LENS AND CORRESPONDING PHOTO / VIDEO NUMBER

TYPES OF DOCUMENTATION


- GROUND BASED PHOTO
- GROUND BASED VIDEO
- 360° SPHERICAL PHOTO
- AERIAL BASED PHOTO
- AERIAL BASED VIDEO

ARCHITECTURAL AS BUILT

Ocala, FL 34470

01	100% SUBMISSION	SEE COVER SHEET
NO.	ISSUES REVISIONS	DATE
SHEET TITLE		
HL	PROJECT MANAGER	
HL	PROJECT DIRECTOR	
012318-1	PROJECT NUMBER	
NO SCALE	SCALE	
CL	DRAWN BY	
	SHEET NUMBER	

SL

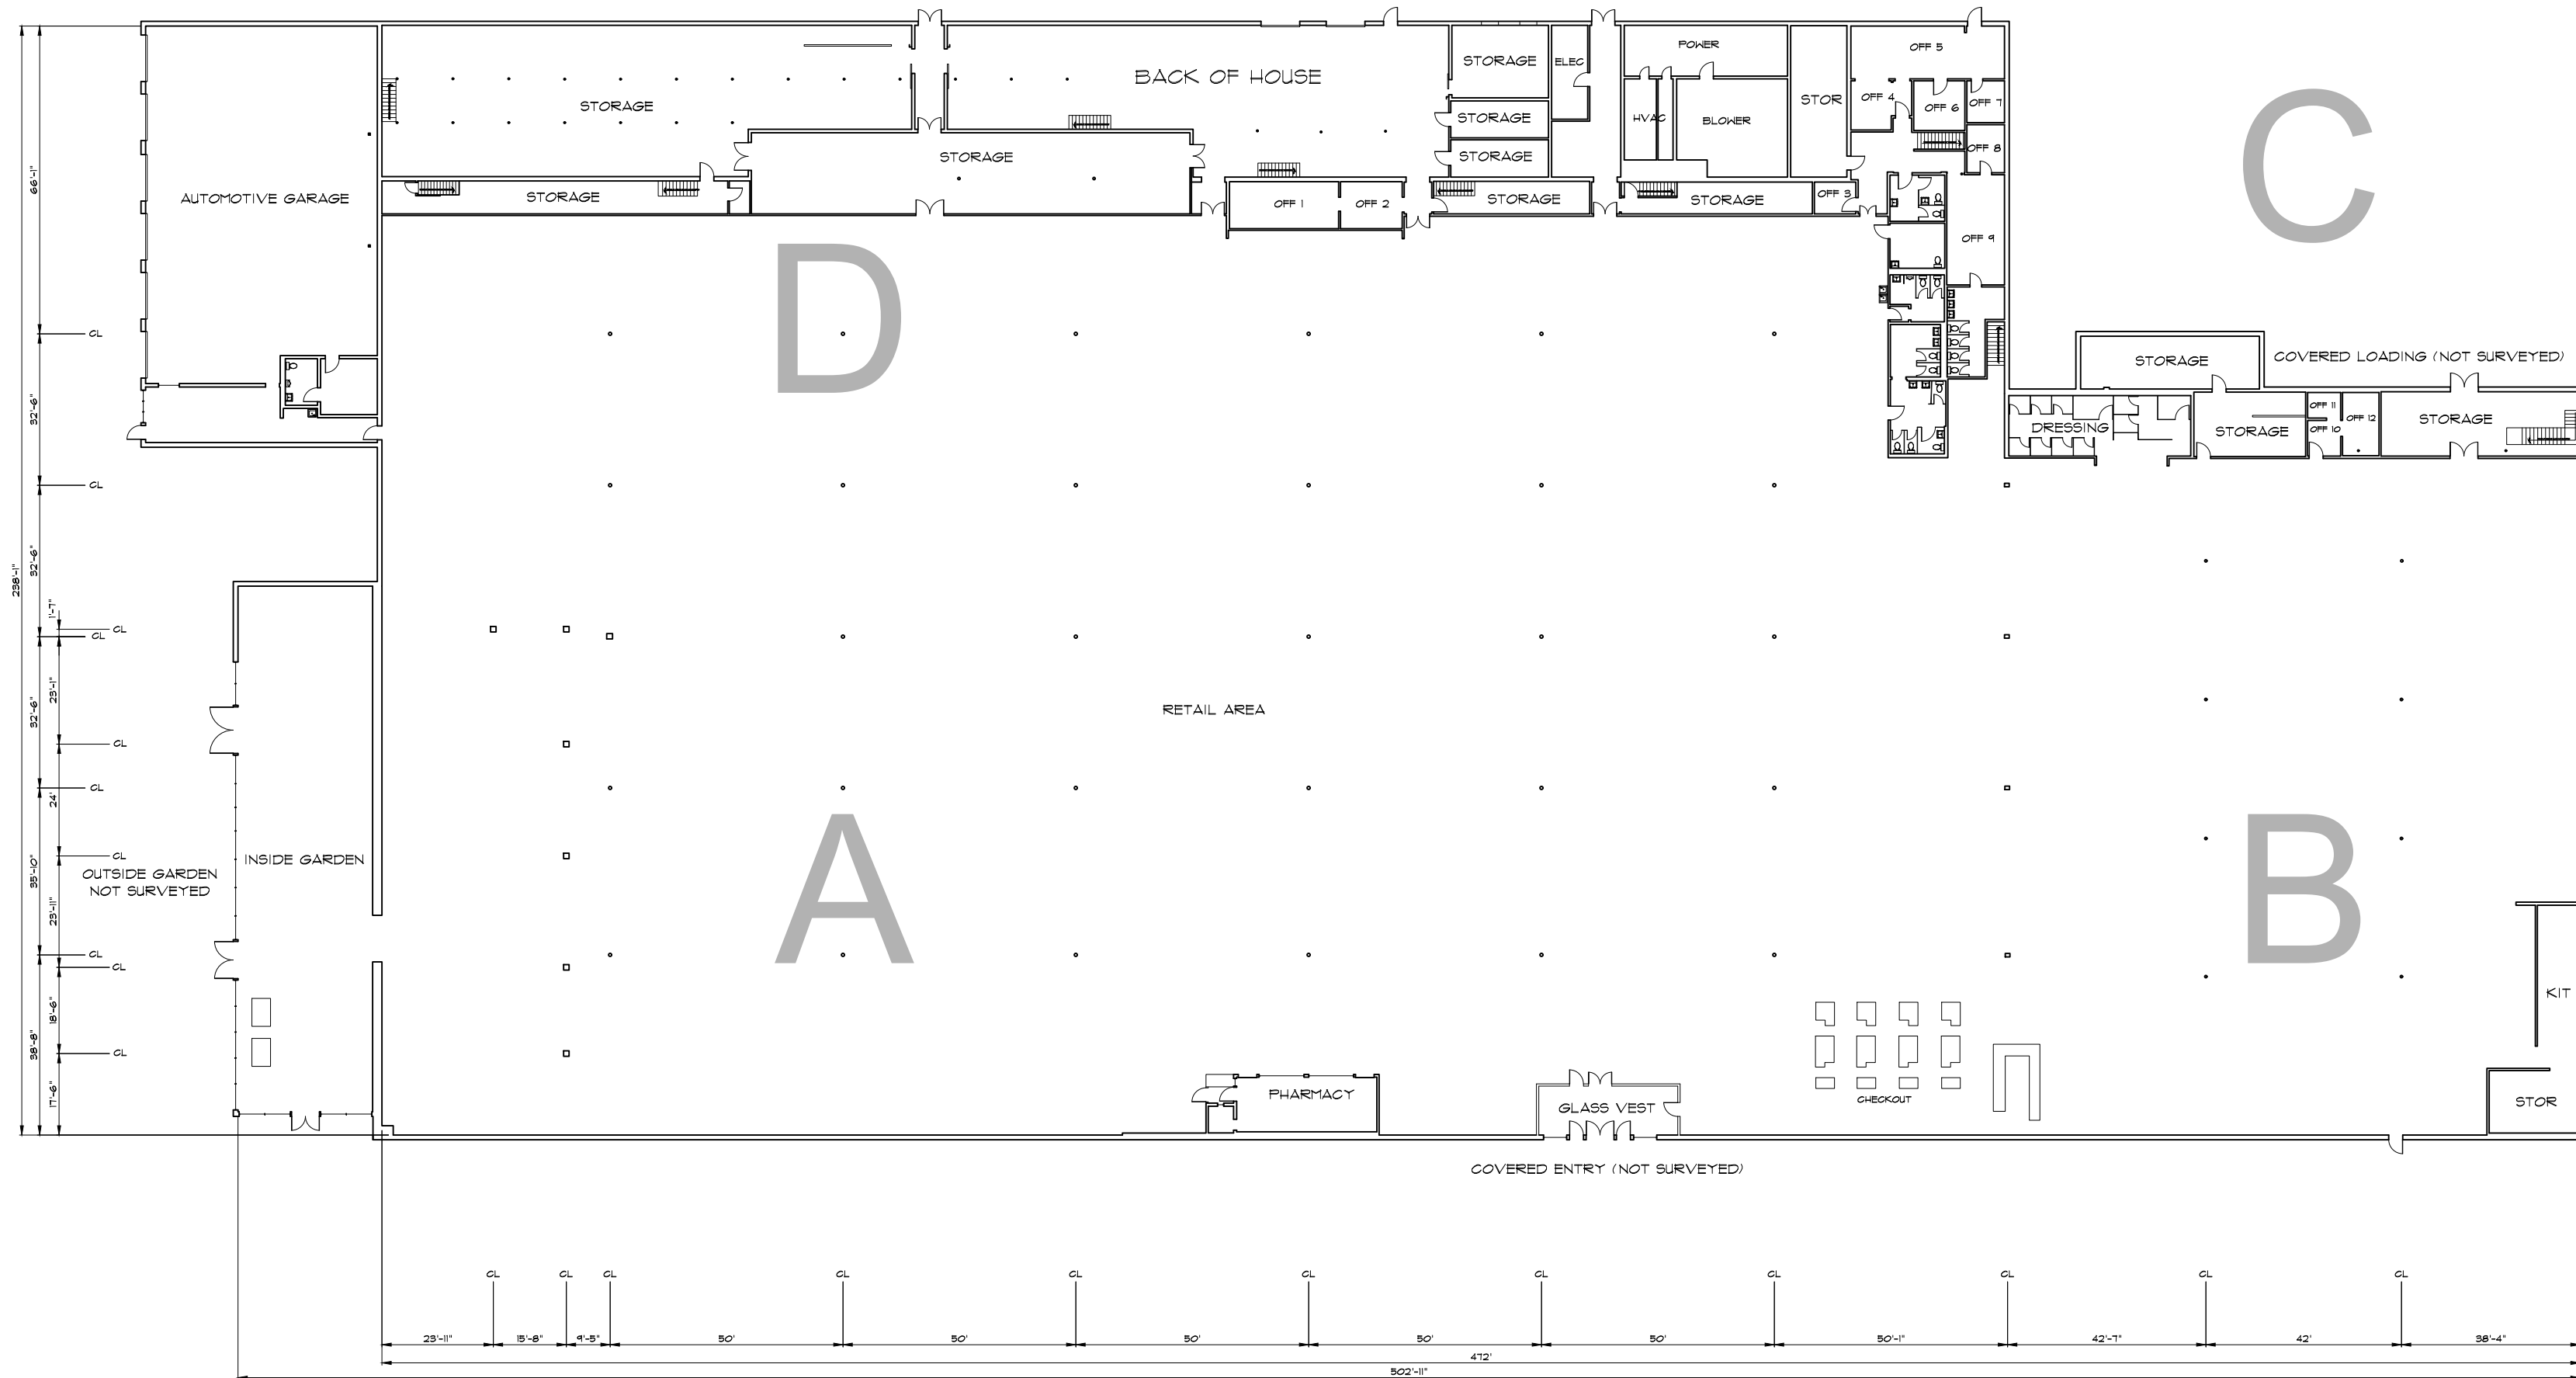

FIRST FLOOR PLAN


ARCHITECTURAL AS BUILT
Ocala, FL 34470

01	100% SUBMISSION	SEE COVER SHEET
NO.	ISSUES REVISIONS	DATE

SHEET TITLE	
HL	PROJECT MANAGER
HL	PROJECT DIRECTOR
012318-1	PROJECT NUMBER
1/32"=1'-0"	SCALE
CL	DRAWN BY
	SHEET NUMBER

AB-1

ARCHITECTURAL AS BUILT
Ocala, FL 34470

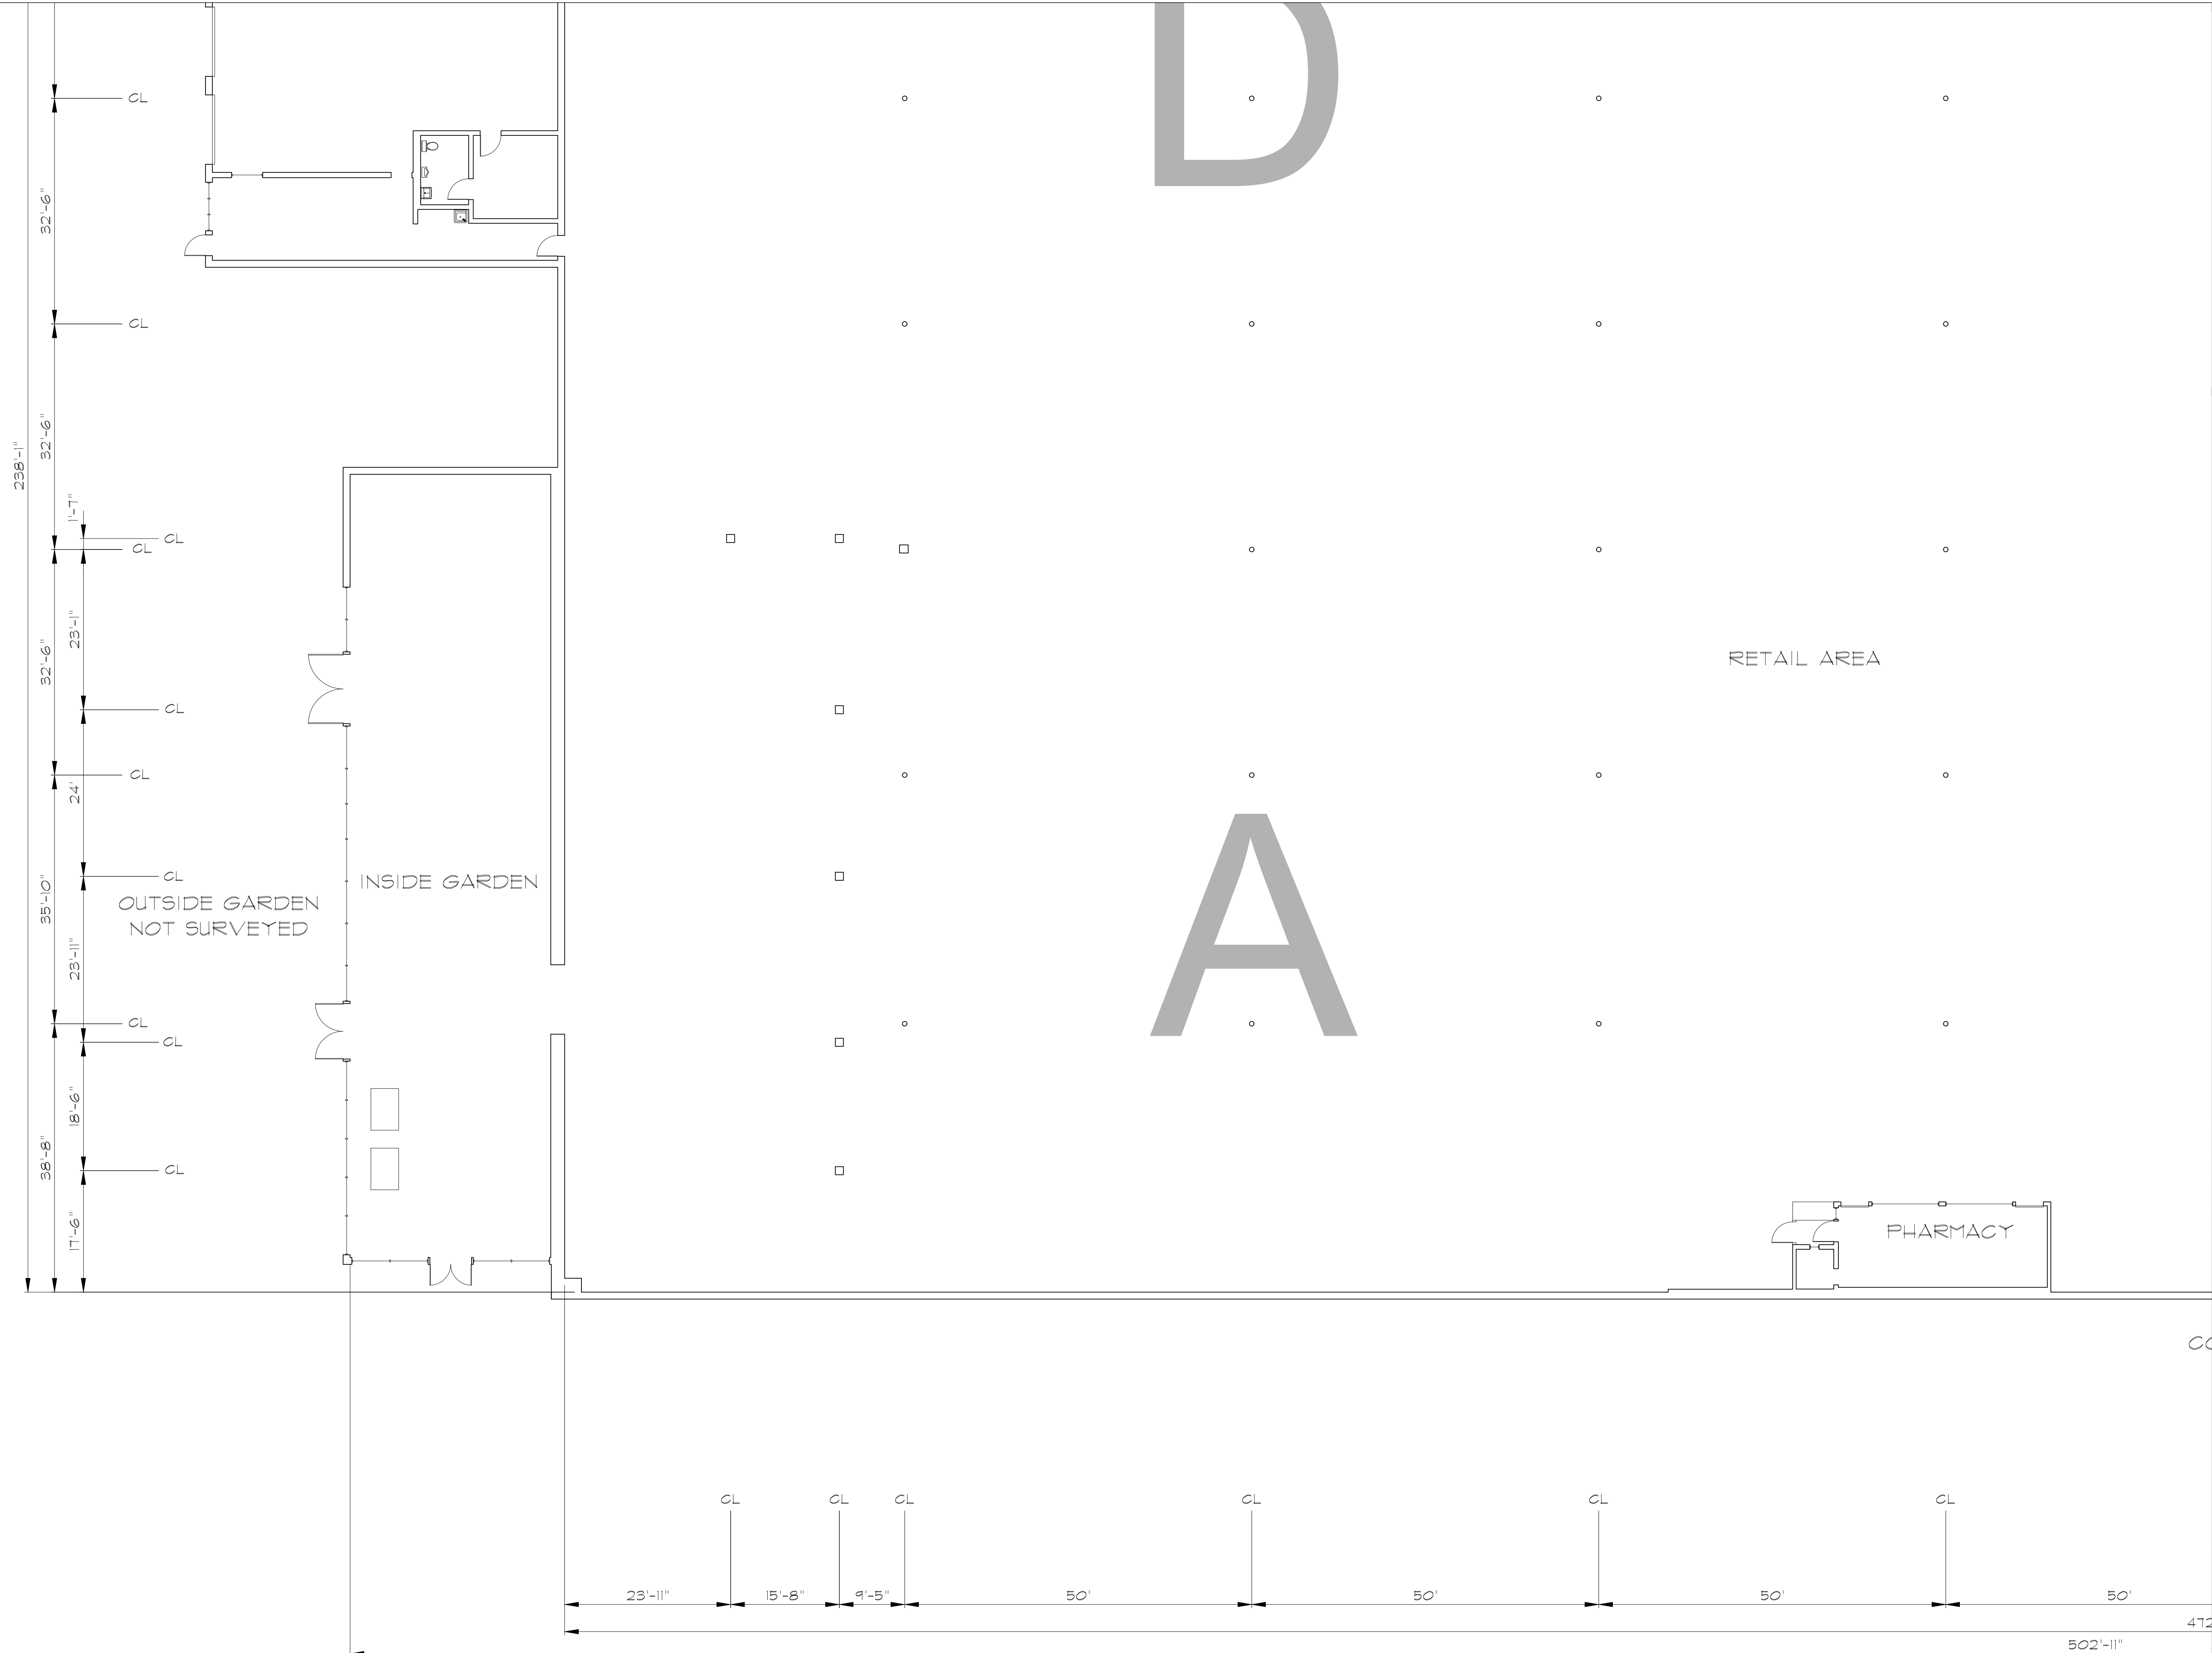

RETAIL AREA




NO.	ISSUES REVISIONS	DATE	SHEET TITLE
01	100% SUBMISSION		SEE COVER SHEET




HL	PROJECT MANAGER
HL	PROJECT DIRECTOR
012318-1	PROJECT NUMBER
3/32"=1'-0"	SCALE
CL	DRAWN BY
	SHEET NUMBER

AB-2


RETAIL AREA

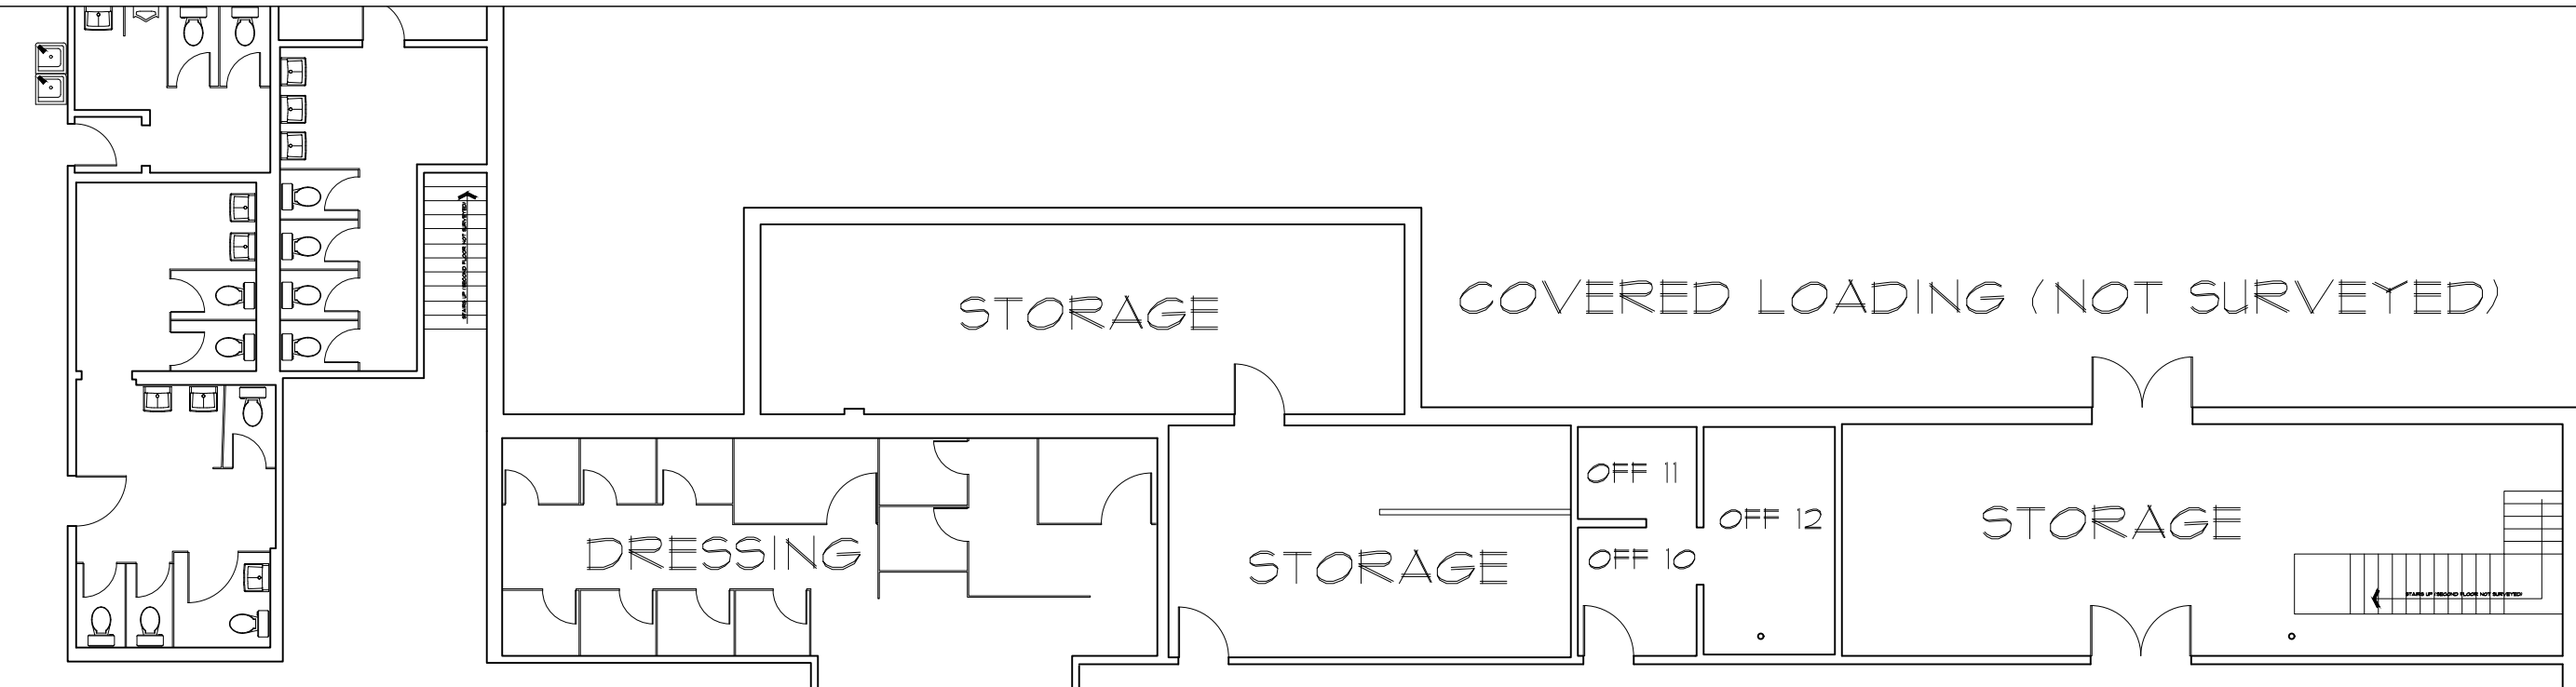

B

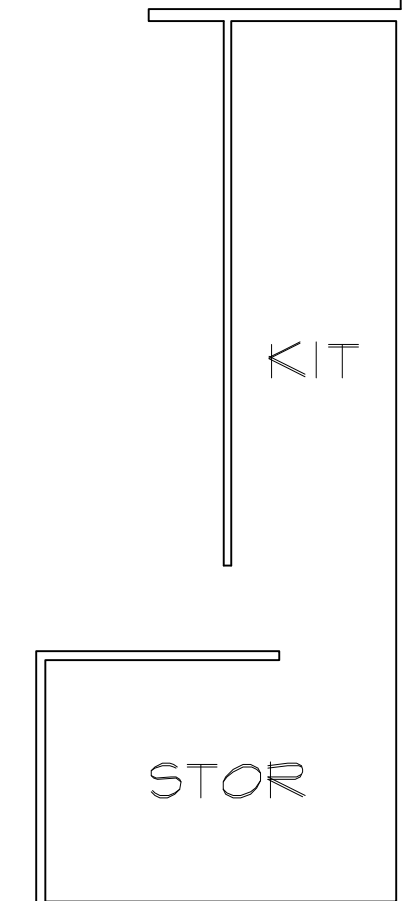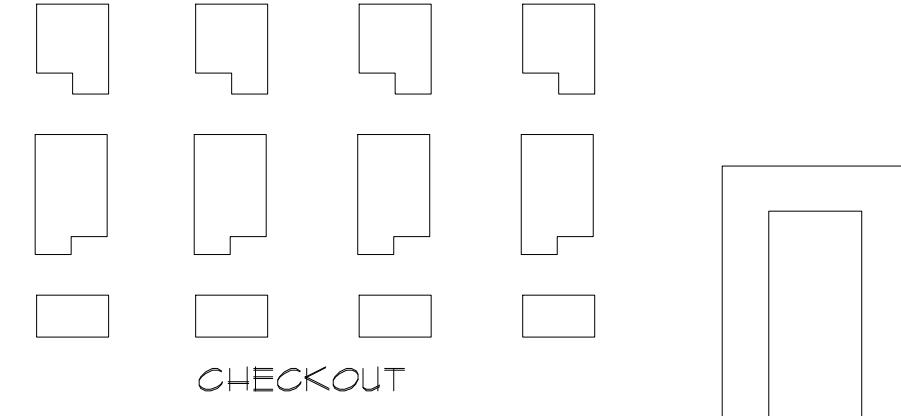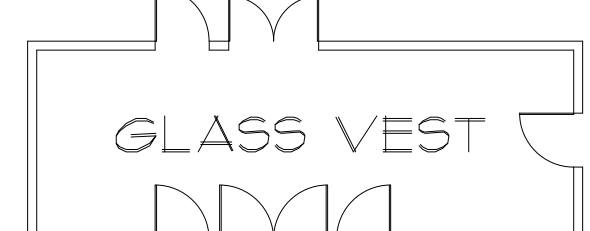

COVERED ENTRY (NOT SURVEYED)

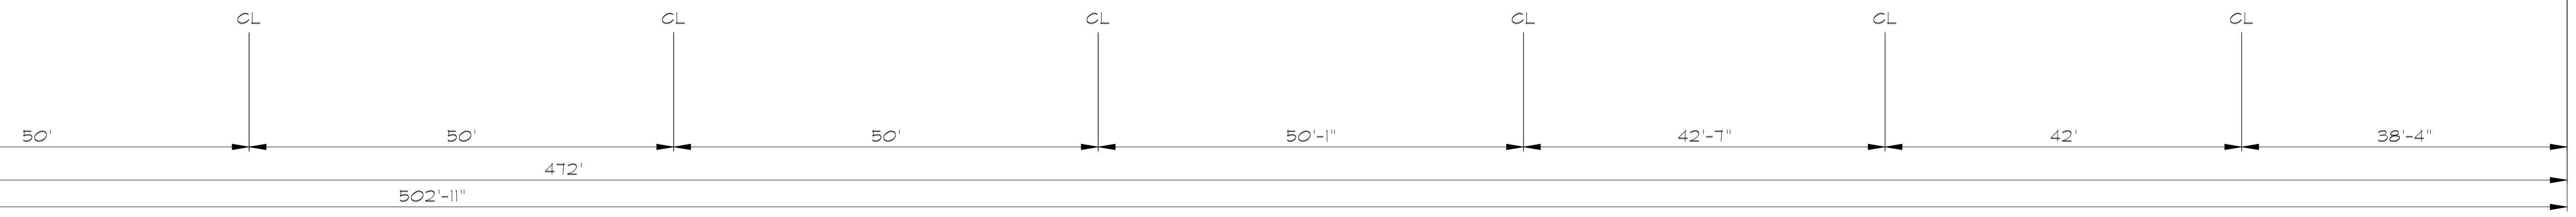

AS BUILT
PROFESSIONALS

www.asbuiltprofessionals.com

A DIVISION OF:

AEC

CONSULTANTS
INC

844.272.8458
844 ASBUILT

© 2014 AEC CONSULTANTS INC


ARCHITECTURAL AS BUILT

Ocala, FL 34470

01	100% SUBMISSION	SEE COVER SHEET
NO.	ISSUES REVISIONS	DATE

HL	PROJECT MANAGER
HL	PROJECT DIRECTOR
012318-1	PROJECT NUMBER
3/32"=1'-0"	SCALE
CL	DRAWN BY
	SHEET NUMBER

AB-3

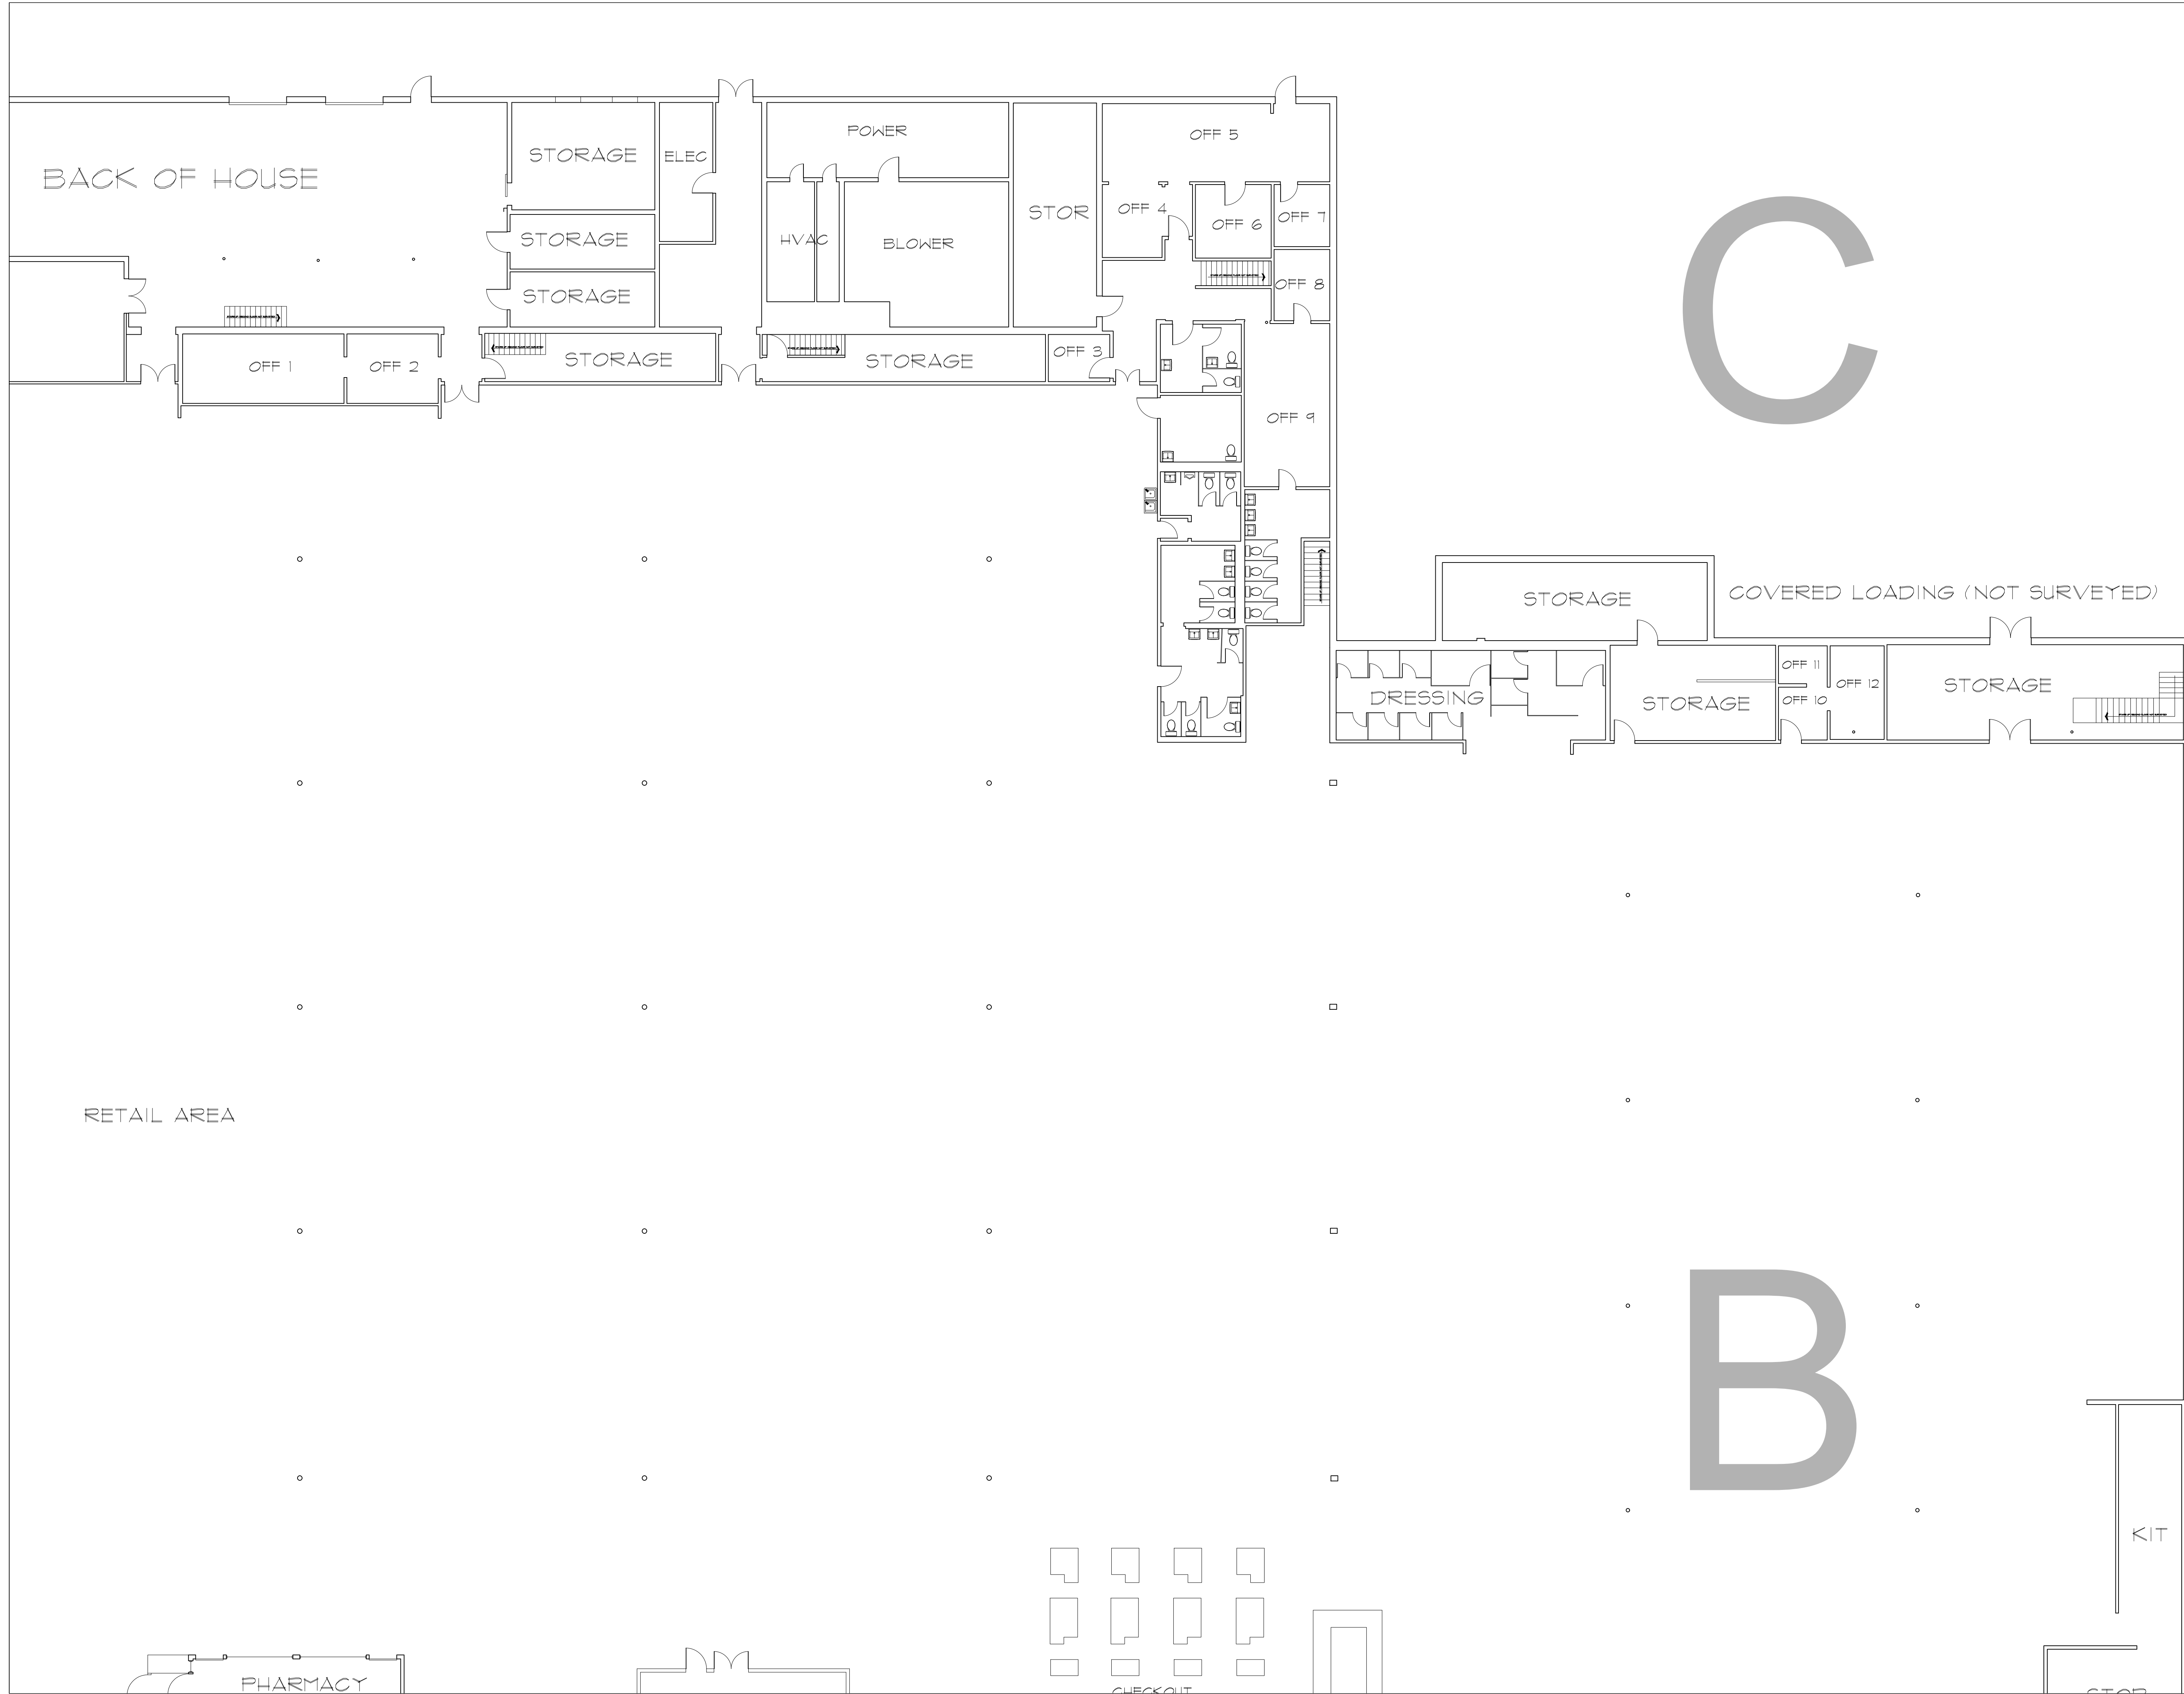

AS BUILT
PROFESSIONALS
 www.asbuiltprofessionals.com
 A DIVISION OF:

AEC
 CONSULTANTS
 INC
 844.272.8458
 844 ASBUILT

© 2014 AEC CONSULTANTS INC

ARCHITECTURAL AS BUILT


Ocala, FL 34470

NO.	ISSUES REVISIONS	DATE	SHEET TITLE
01	100% SUBMISSION		SEE COVER SHEET

HL	PROJECT MANAGER
HL	PROJECT DIRECTOR
012318-1	PROJECT NUMBER
3/32"=1'-0"	SCALE
CL	DRAWN BY
	SHEET NUMBER

AB-4

ARCHITECTURAL AS BUILT
Ocala, FL 34470

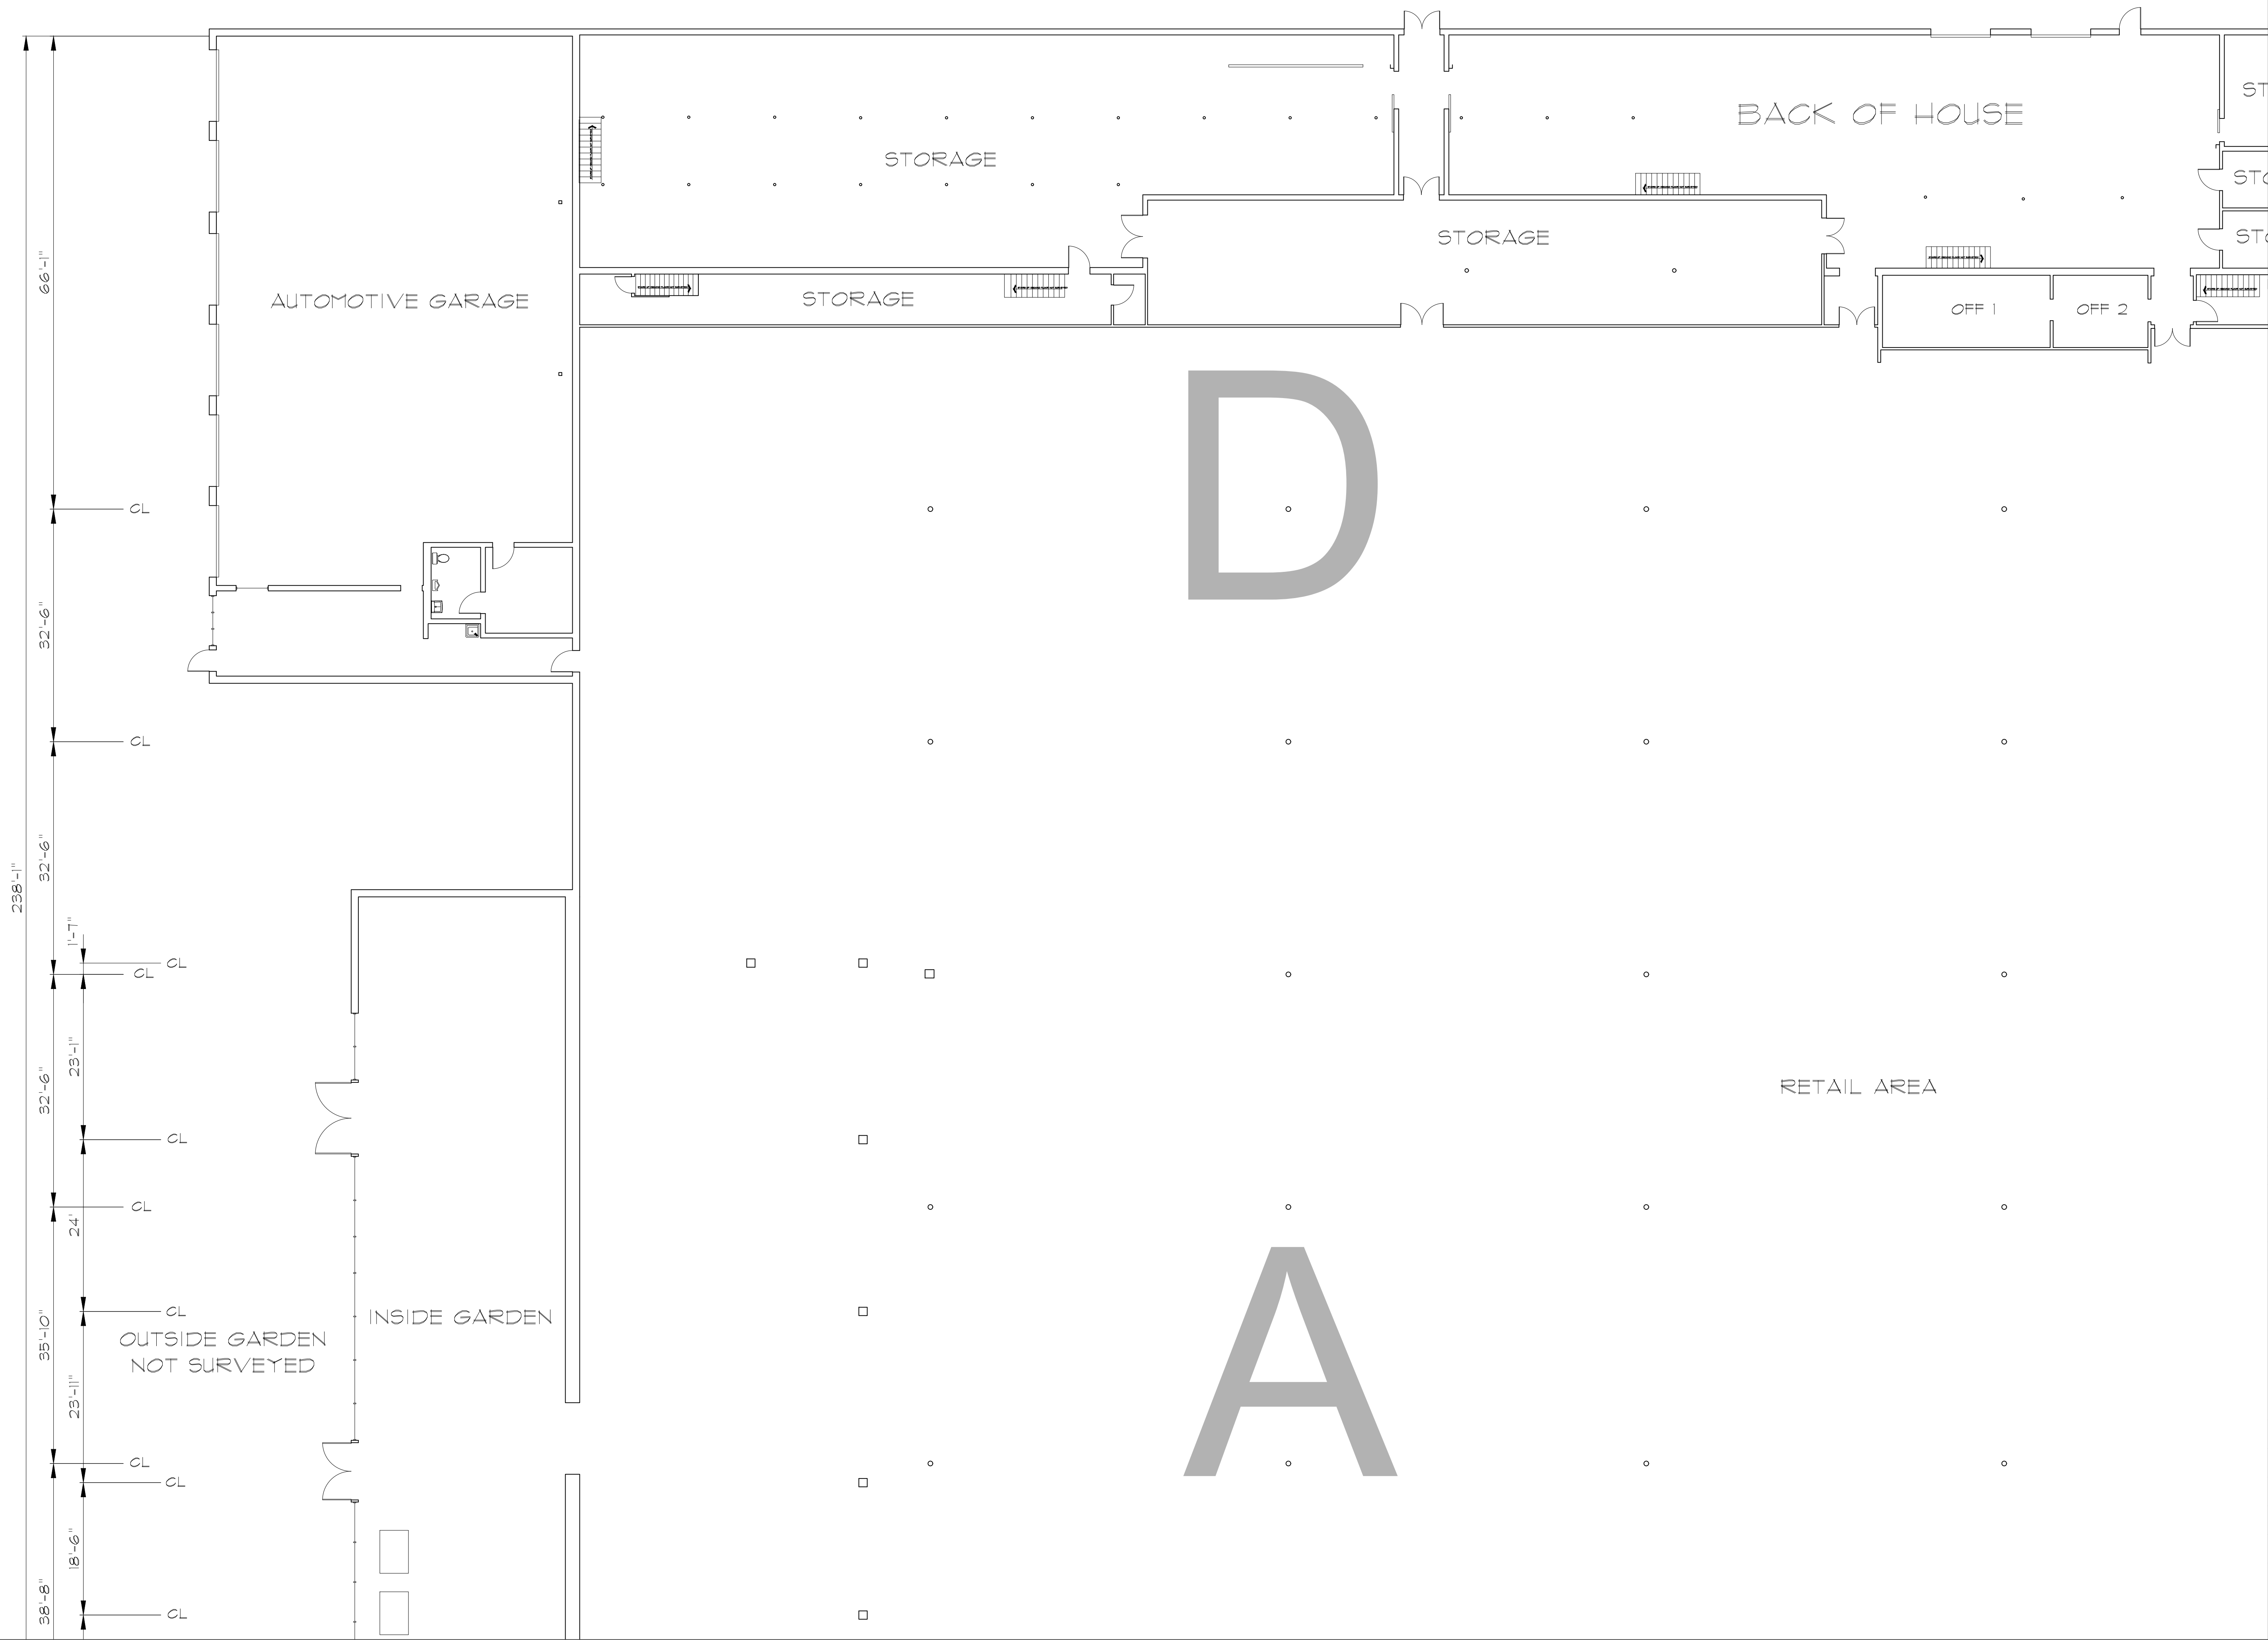

NO.	ISSUES REVISIONS	DATE	SHEET TITLE
01	100% SUBMISSION		SEE COVER SHEET

HL	PROJECT MANAGER
HL	PROJECT DIRECTOR
012318-1	PROJECT NUMBER
3/16"=1'-0"	SCALE
CL	DRAWN BY
	SHEET NUMBER

AB-5