

SYMBOLS LEGEND

RCP

- EXHAUST VENT
- CEILING MOUNTED LIGHT FIXTURE
- CEILING MOUNTED DIRECTIONAL LIGHT
- RECESSED CAN LIGHT
- EYEBALL OR SMALL CAN LIGHT
- PENDANT LIGHT
- INDIVIDUAL FLUOR. LAY-IN FIXTURE 4 BULB
- INDIVIDUAL FLUOR. HANGING FIXTURE 2 BULB
- INDIVIDUAL FLUOR. FLUSH MOUNT FIXTURE 4 BULB
- CAMERA
- MOTION DET.
- SUPPLY VENT
- SUPPLY VENT
- RETURN VENT
- RETURN VENT
- SPEAKER

- TRACK LIGHT OR VANITY LIGHT
- WALL-MOUNTED LIGHT FIXTURE
- EMERGENCY EXIT SIGN
- EMERGENCY EXIT LIGHT
- EMERGENCY EXIT LIGHT W/ SIGN
- LIGHTED STAIR SIGN
- FLOOD LIGHT
- PHOTO CELL
- CEILING FAN
- CEILING FAN W/ LIGHT KIT
- 7-2-6** CEILING HEIGHT AND TRIM 1'-2" ABOVE FLOOR BELOW WITH 6" CROWN MOULDING. NOTE: ALL CEILINGS NOT LABELED ARE PLASTER. CEILINGS SHOWN WITH A GRID ARE LAY IN ACOUSTICAL TILE..
- JUNCTION BOX

ELECTRIC

- DATA OUTLET
- TELEPHONE JACK
- ELECTRIC SWITCH
- CABLE TELEVISION OUTLET
- DUPLEX RECEPTACLE OUTLET
- SPECIAL PURPOSE CONNECTION OR OUTLET
- QUADRUPLEX RECEPTACLE OUTLET
- FLOOR DUPLEX RECEPTACLE OUTLET
- ELECTRIC PANEL
- ELECTRIC METER
- BUTTON SWITCH
- DISCONNECT SWITCH
- GROUND/FLOOR LIGHT
- KEY PAD

FIRE PROTECTION




- FIRE EXTINGUISHER
- FIRE PULL
- FIRE ALARM (HORN/SRTO)
- SMOKE DETECTOR
- SMOKE ALARM SPEAKER
- SPRINKLER HEAD CEILING MOUNT
- SPRINKLER HEAD WALL MOUNT

MEP

- THERMOSTAT
- FLOOR DRAIN
- VALVE
- HOSE BIB
- WATER SUPPLY
- SUSPENDED GAS HEATER

MISC

- BOLLARD
- SPOT ELEVATION

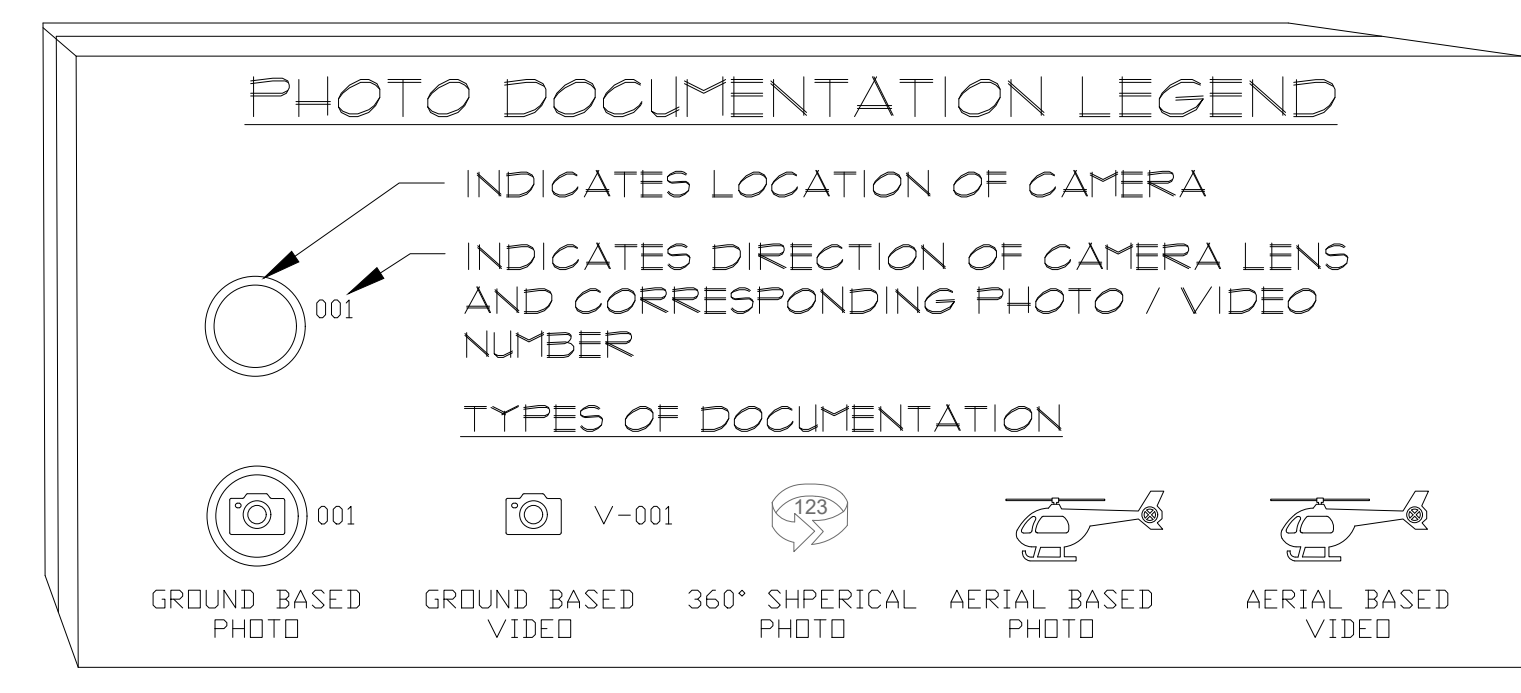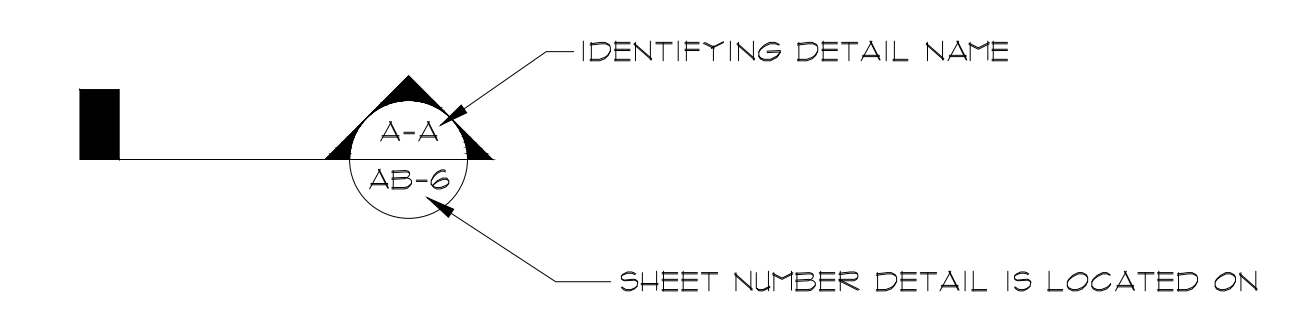
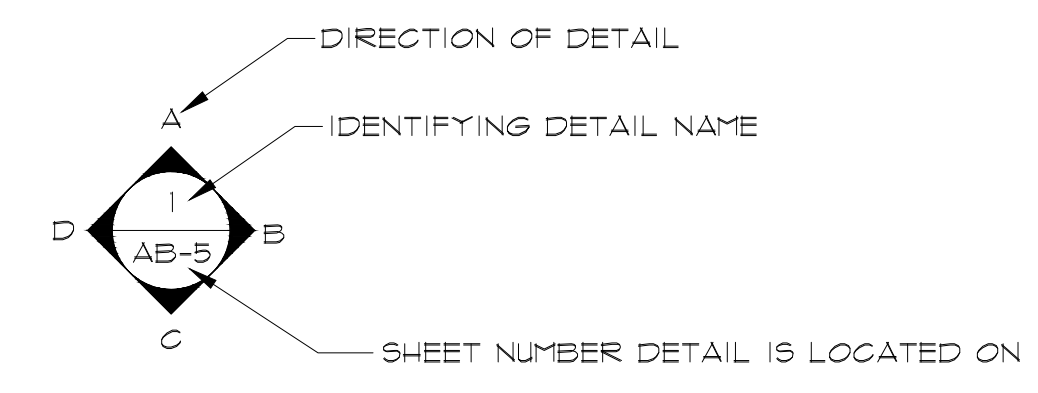


ARCHITECTURAL AS BUILT

Temple Terrace, FL 33617

01	100% SUBMISSION	SEE COVER SHEET
NO.	ISSUES REVISIONS	DATE
SHEET TITLE		
HL	PROJECT MANAGER	
HL	PROJECT DIRECTOR	
012318-1	PROJECT NUMBER	
NO SCALE	SCALE	
CL	DRAWN BY	
	SHEET NUMBER	

SL

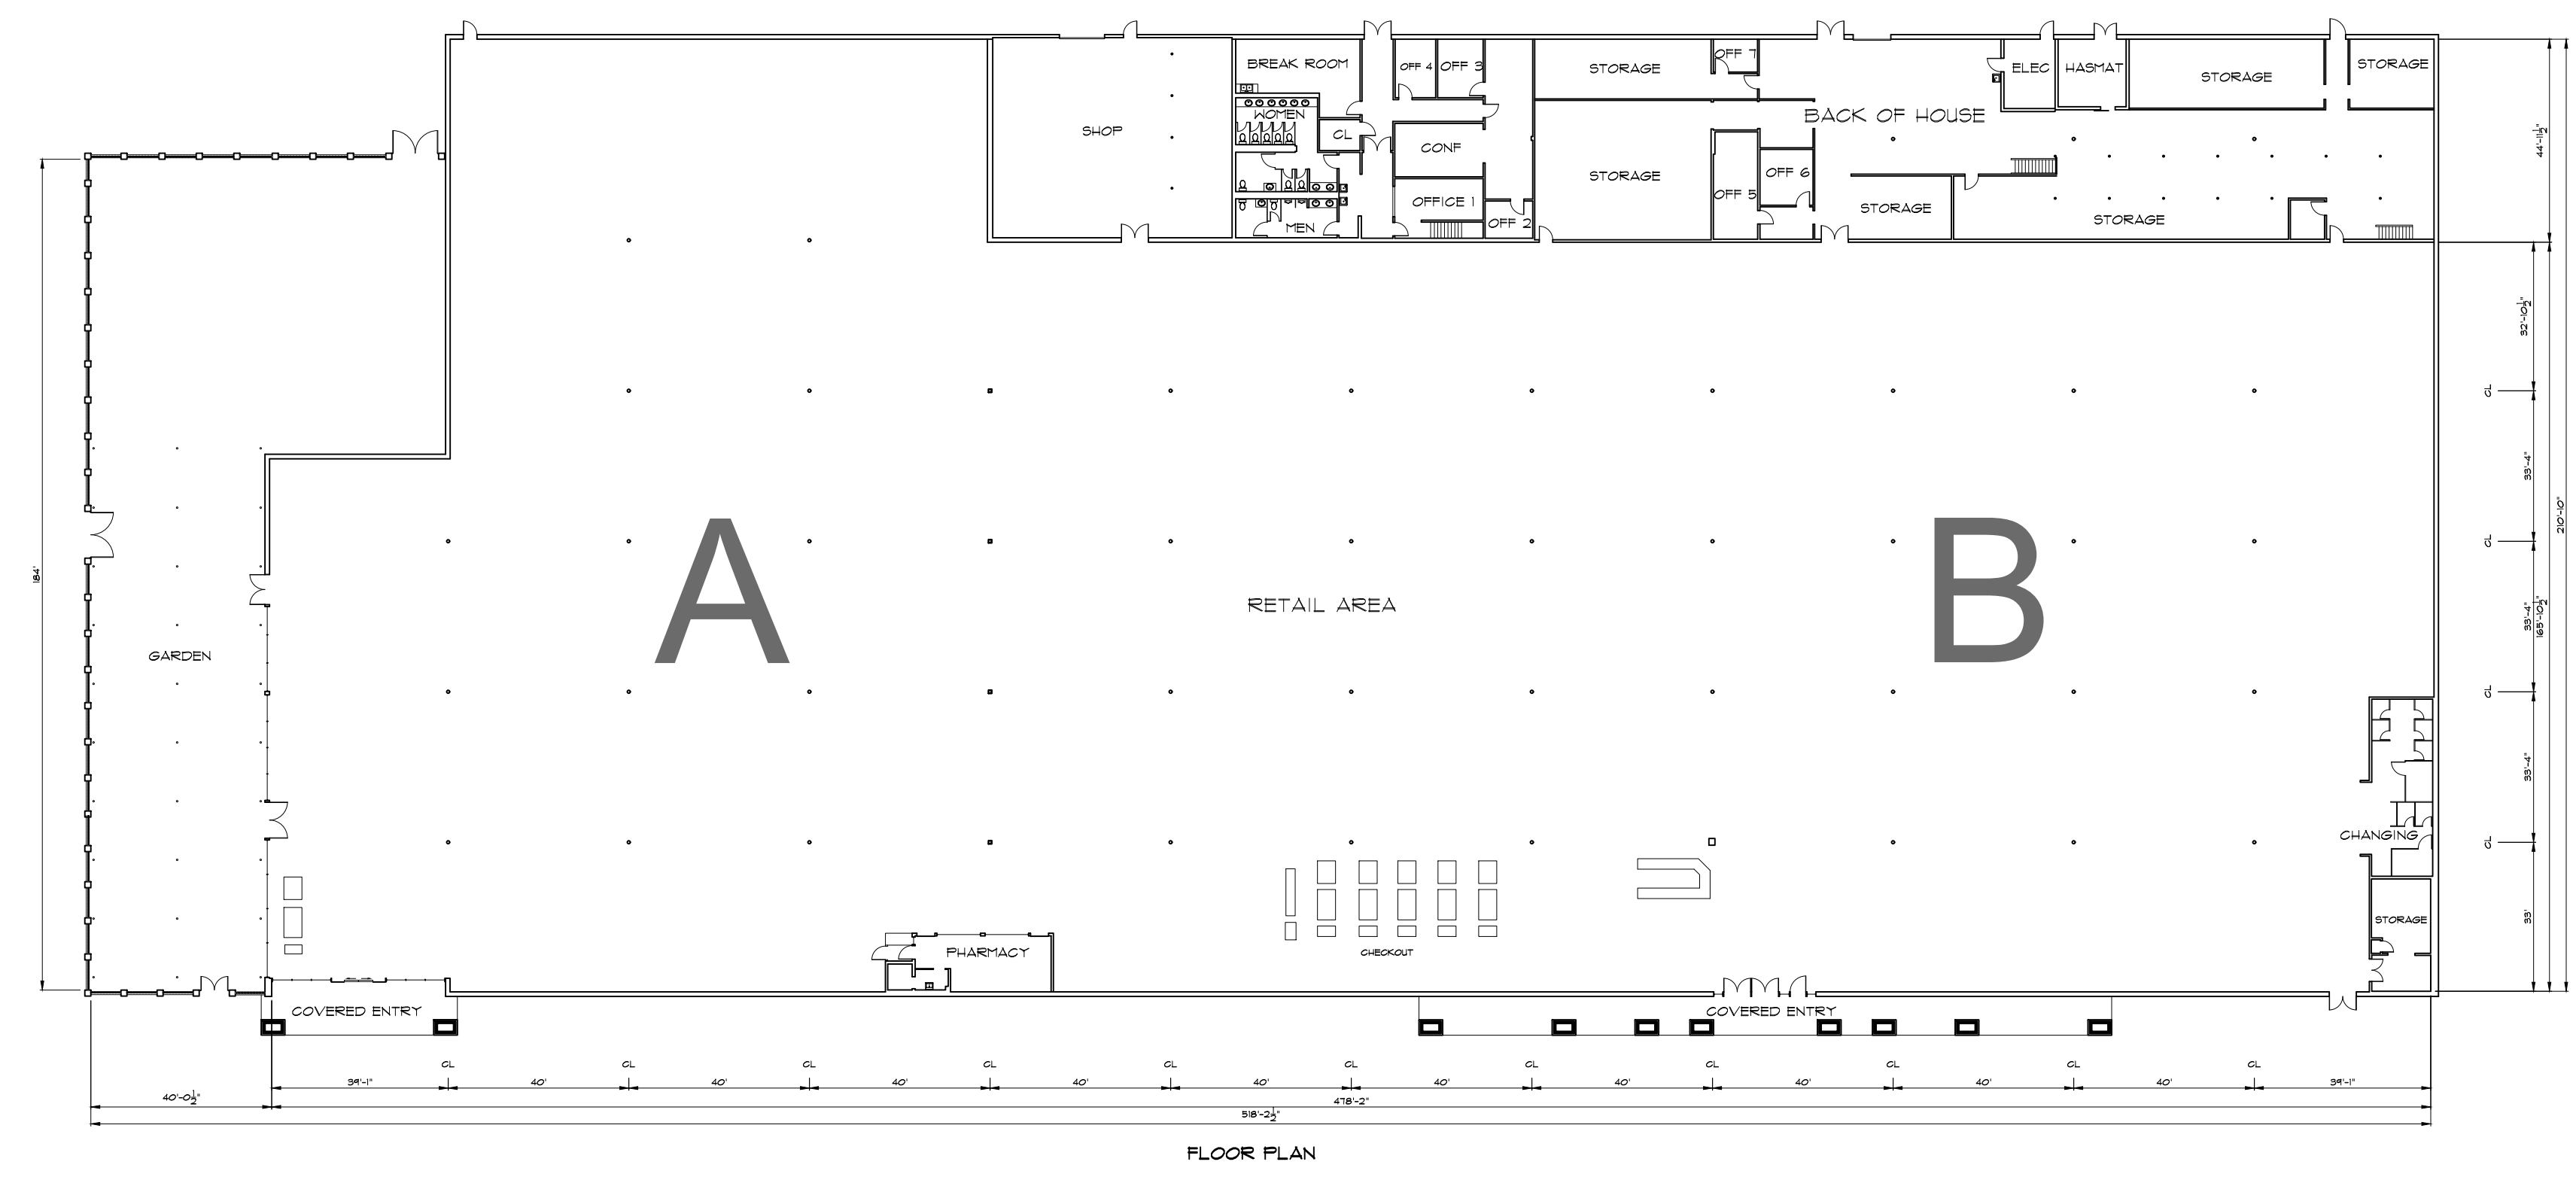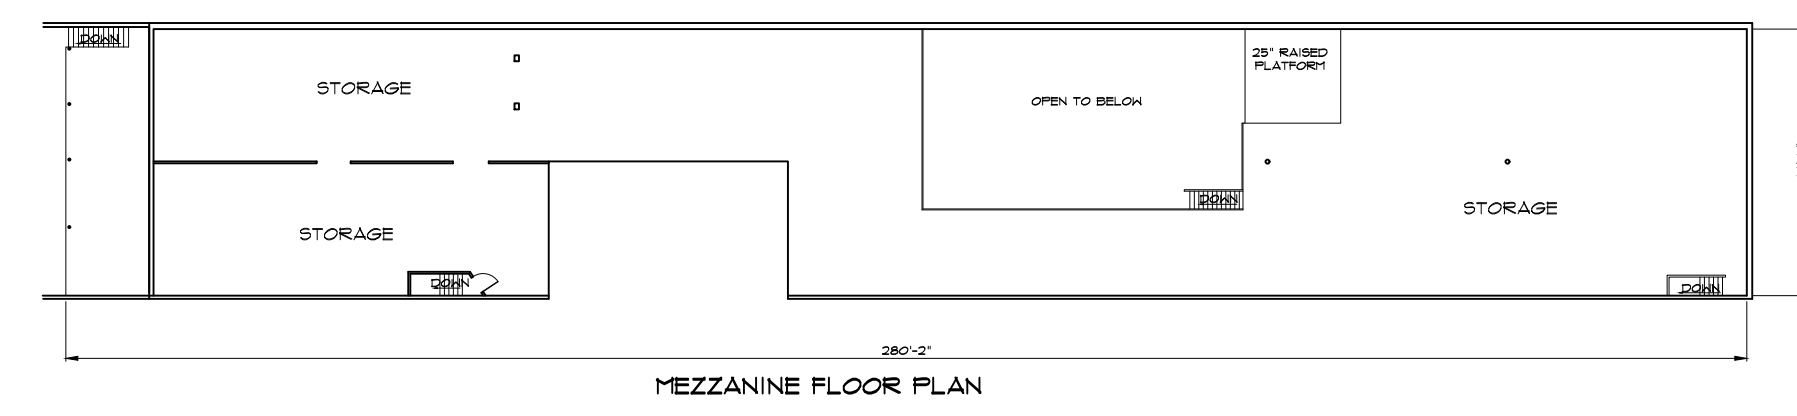

ARCHITECTURAL AS BUILT
Temple Terrace, FL 33617


01	100% SUBMISSION	SEE COVER SHEET
NO.	ISSUES REVISIONS	DATE

SHEET TITLE	
HL	PROJECT MANAGER
HL	PROJECT DIRECTOR
012318-1	PROJECT NUMBER

1/32"=1'-0"	SCALE
CL	DRAWN BY
	SHEET NUMBER

AB-1

ARCHITECTURAL AS BUILT
Temple Terrace, FL 33617

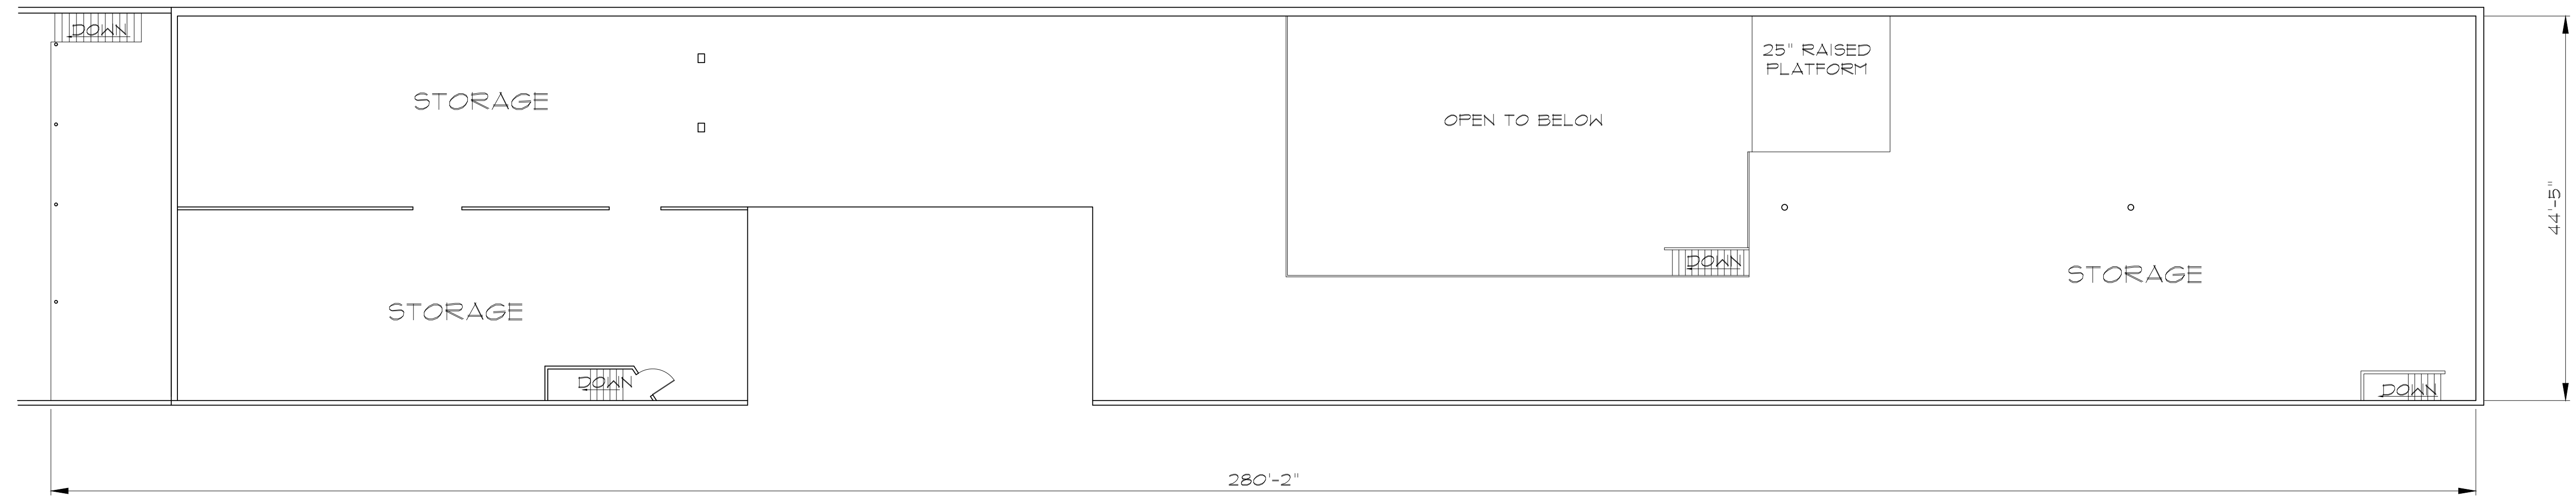

MEZZANINE FLOOR PLAN

NO.	ISSUES REVISIONS	DATE	SEE COVER SHEET
01	100% SUBMISSION		SEE COVER SHEET

SHEET TITLE

HL PROJECT MANAGER

HL PROJECT DIRECTOR

012318-1 PROJECT NUMBER

3/32"=1'-0" SCALE

CL DRAWN BY

SHEET NUMBER

AB-4