

AS-BUILT DOCUMENTATION


LINCOLN LUMBER

DRAWING INDEX

- C-1 COVER SHEET | DRAWING INDEX
- SL SYMBOLS LEGEND
- AB-1 FIRST FLOOR PLAN
- AB-2 BREAK AREA FIRST FLOOR PLAN
- AB-3 MEZZANINE FLOOR PLAN



ARCHITECTURAL AS BUILT
LINCOLN LUMBER
 Union Point, GA 30669

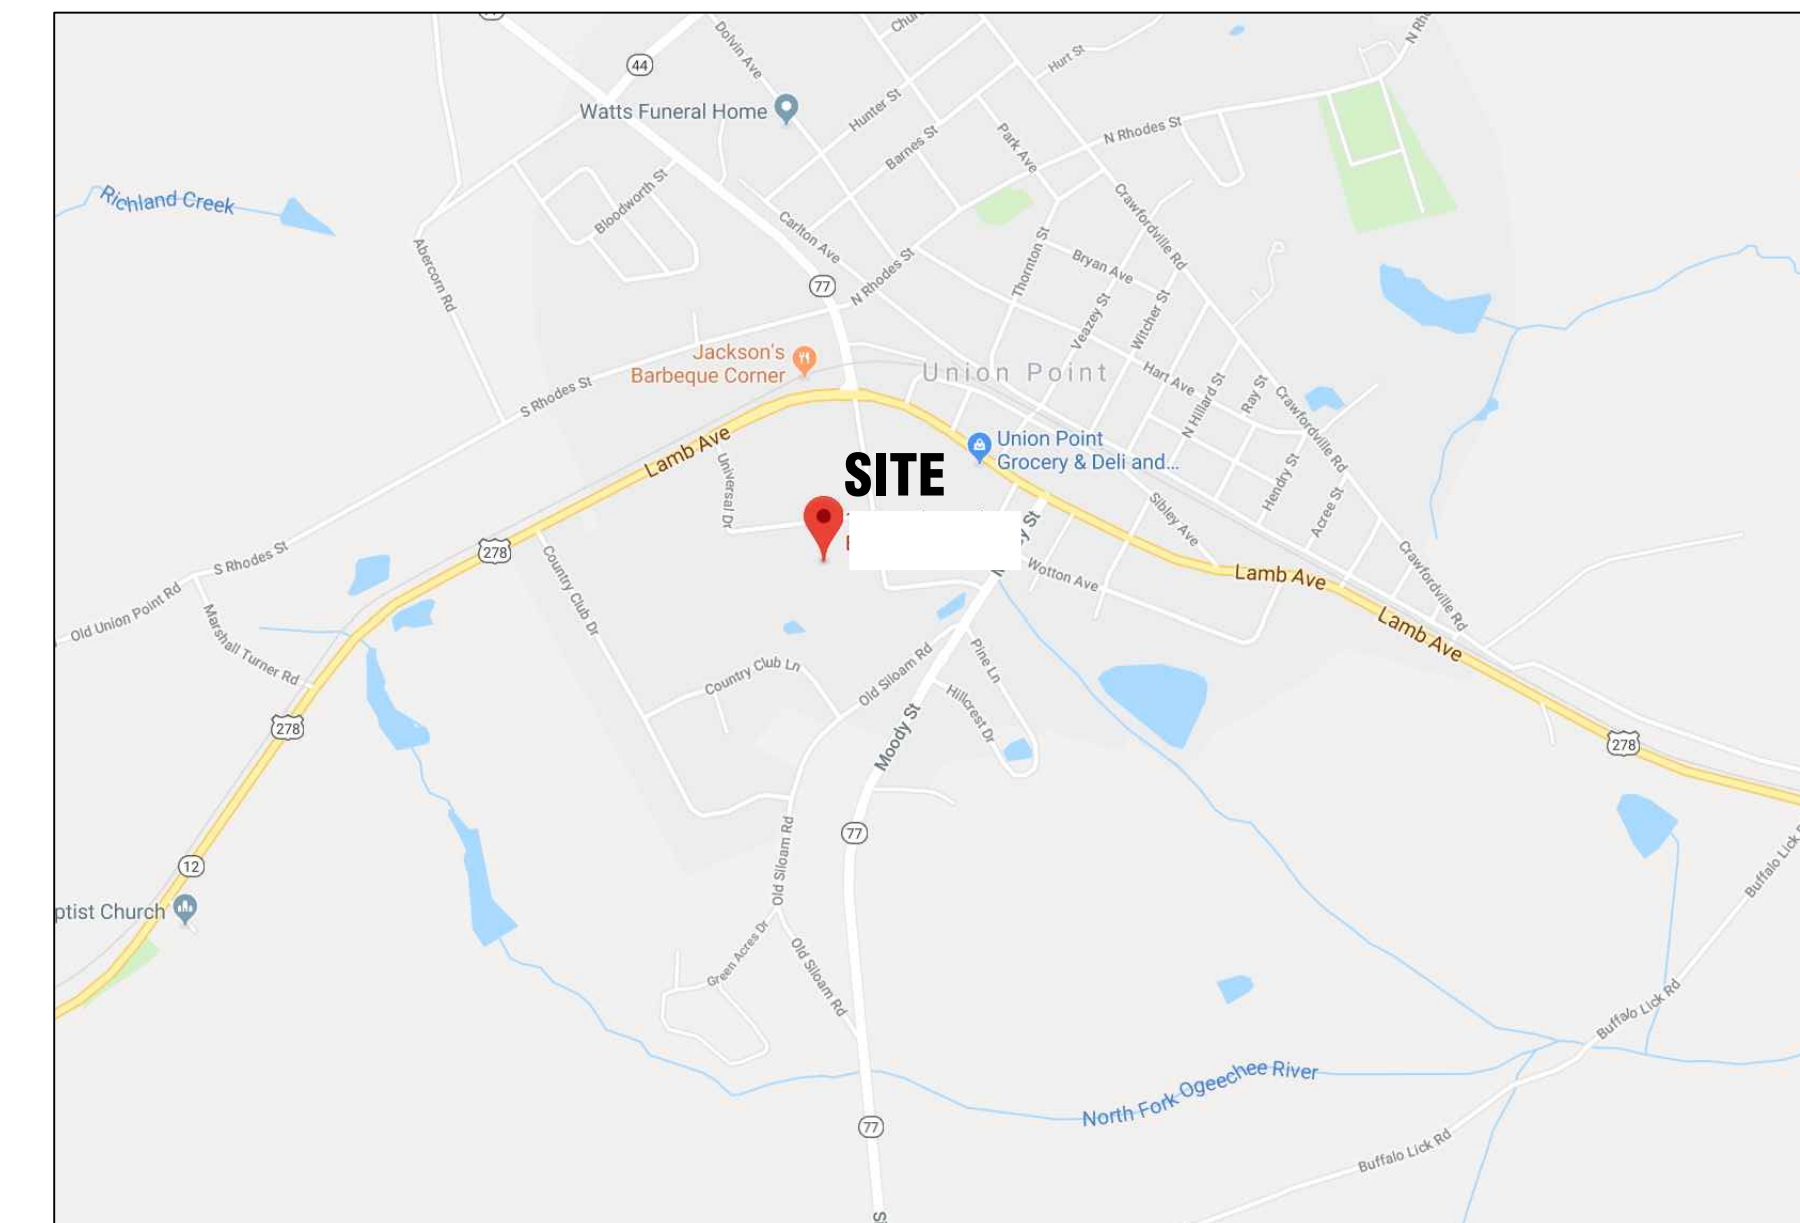

VICINITY MAP
NTS

AREA DATA	
FIRST FLOOR	81,920 S.F. ±
MEZZANINE AREAS	1,068 S.F. ±
OUTSIDE COVERED BREAK AREA	423 S.F. ±
GRAND TOTAL	83,411 S.F. ±

100% SUBMITTAL

COVER SHEET		
O1	100% SUBMISSION	SEE COVER SHEET
NO.	ISSUES REVISIONS	DATE
SHEET TITLE		
COVER SHEET		
HL	PROJECT MANAGER	
HL	PROJECT DIRECTOR	
012318-1	PROJECT NUMBER	
	SCALE	
CL	DRAWN BY	
	SHEET NUMBER	
C-1		

SYMBOLS LEGEND

RCP

	EXHAUST VENT		TRACK LIGHT OR VANITY LIGHT
	CEILING MOUNTED LIGHT FIXTURE		WALL-MOUNTED LIGHT FIXTURE
	CEILING MOUNTED DIRECTIONAL LIGHT		EMERGENCY EXIT SIGN
	RECESSED CAN LIGHT		EMERGENCY EXIT LIGHT
	EYEBALL OR SMALL CAN LIGHT		EMERGENCY EXIT LIGHT W/ SIGN
	PENDANT LIGHT		LIGHTED STAIR SIGN
	INDIVIDUAL FLUOR. LAY-IN FIXTURE 4 BULB		FLOOD LIGHT
	INDIVIDUAL FLUOR. HANGING FIXTURE 2 BULB		PHOTO CELL
	INDIVIDUAL FLUOR. FLUSH MOUNT FIXTURE 4 BULB		CEILING FAN
	CAMERA		CEILING FAN W/ LIGHT KIT
	MOTION DET.	7-2-6	CEILING HEIGHT AND TRIM 1'-2" ABOVE FLOOR BELOW WITH 6" CROWN MOULDING. NOTE: ALL CEILINGS NOT LABELED ARE PLASTER. CEILINGS SHOWN WITH A GRID ARE LAY IN ACOUSTICAL TILE..
	SUPPLY VENT		JUNCTION BOX
	SUPPLY VENT		
	RETURN VENT		
	RETURN VENT		
	SPEAKER		

ELECTRIC

	DATA OUTLET
	TELEPHONE JACK
	ELECTRIC SWITCH
	CABLE TELEVISION OUTLET
	DUPLEX RECEPTACLE OUTLET
	SPECIAL PURPOSE CONNECTION OR OUTLET
	QUADRUPLEX RECEPTACLE OUTLET
	FLOOR DUPLEX RECEPTACLE OUTLET
	ELECTRIC PANEL
	ELECTRIC METER
	BUTTON SWITCH
	DISCONNECT SWITCH
	GROUND/FLOOR LIGHT
	KEY PAD

FIRE PROTECTION

	FIRE EXTINGUISHER
	FIRE PULL
	FIRE ALARM (HORN/SRTO)
	SMOKE DETECTOR
	SMOKE ALARM SPEAKER
	SPRINKLER HEAD CEILING MOUNT
	SPRINKLER HEAD WALL MOUNT

MEP

	THERMOSTAT
	FLOOR DRAIN
	VALVE
	HOSE BIB
	WATER SUPPLY
	SUSPENDED GAS HEATER

MISC

	BOLLARD
	SPOT ELEVATION

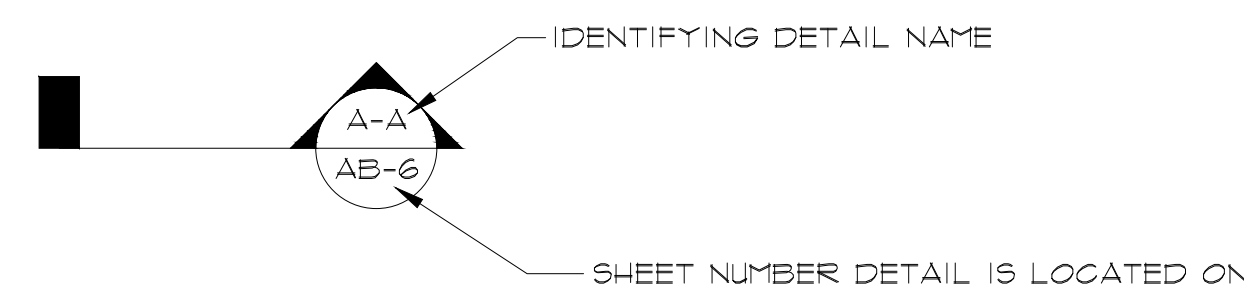
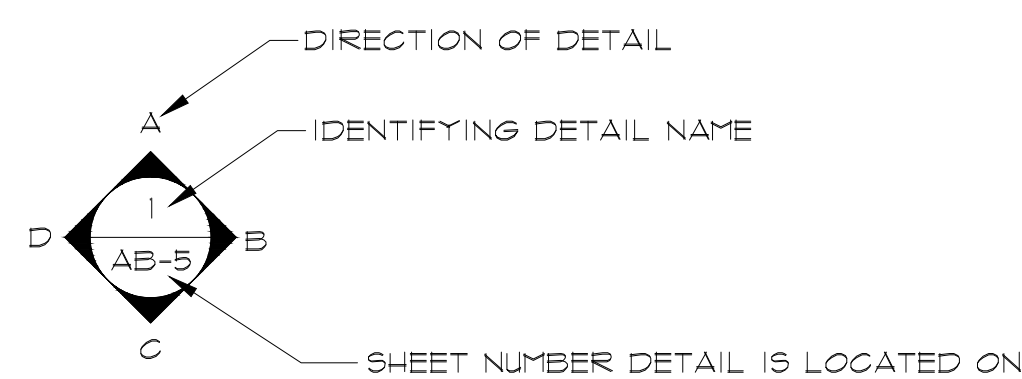


PHOTO DOCUMENTATION LEGEND

INDICATES LOCATION OF CAMERA

INDICATES DIRECTION OF CAMERA LENS AND CORRESPONDING PHOTO / VIDEO NUMBER

TYPES OF DOCUMENTATION

	GROUND BASED PHOTO		GROUND BASED VIDEO		360° SPHERICAL PHOTO		AERIAL BASED PHOTO		AERIAL BASED VIDEO
--	--------------------	--	--------------------	--	----------------------	--	--------------------	--	--------------------


AS BUILT PROFESSIONALS
www.asbuiltprofessionals.com
A DIVISION OF:

AEC CONSULTANTS INC
844.272.8458
844 ASBUILT

© 2018 AEC CONSULTANTS INC

ARCHITECTURAL AS BUILT LINCOLN LUMBER
Union Point, GA 30669

01	100% SUBMISSION	SEE COVER SHEET
NO.	ISSUES REVISIONS	DATE
SHEET TITLE		
HL	PROJECT MANAGER	
HL	PROJECT DIRECTOR	
012318-1	PROJECT NUMBER	
NO SCALE	SCALE	
CL	DRAWN BY	
SHEET NUMBER		
AB-1		

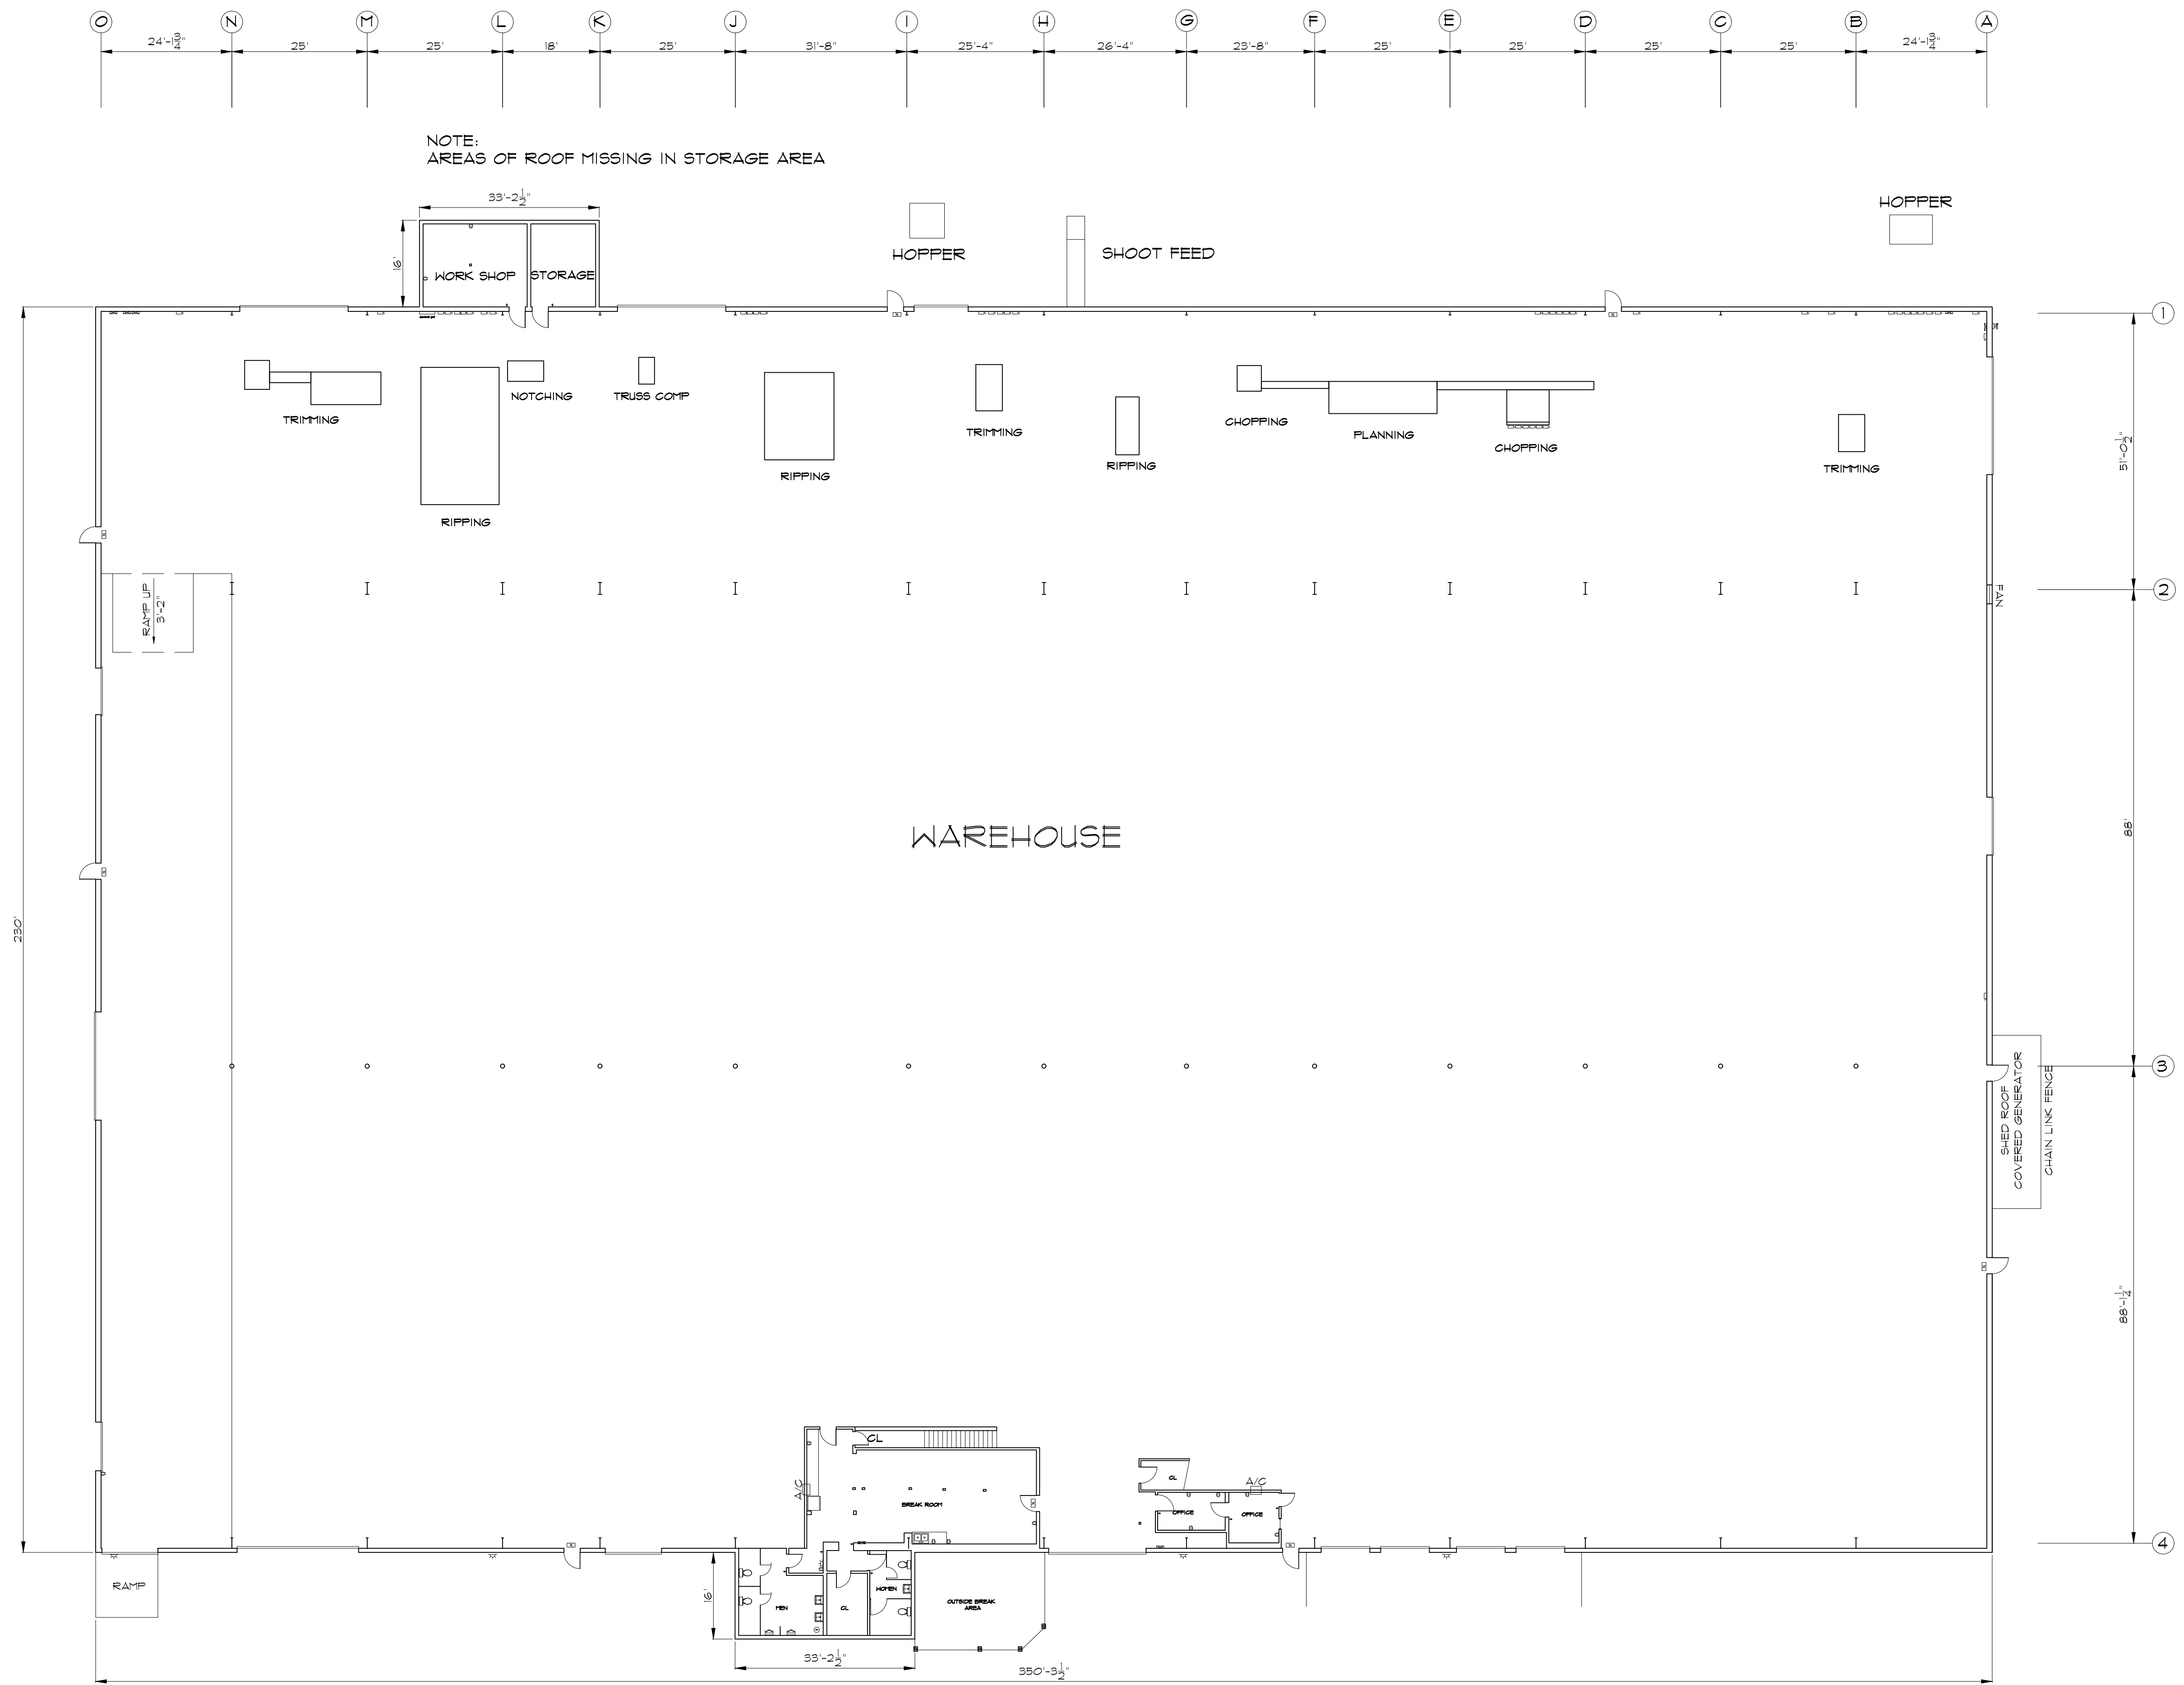

WAREHOUSE FLOOR PLAN



**ARCHITECTURAL AS BUILT
LINCOLN LUMBER**

Union Point, GA 30669

01	100% SUBMISSION	SEE COVER SHEET
NO.	ISSUES REVISIONS	DATE


SHEET TITLE

HL	PROJECT MANAGER
HL	PROJECT DIRECTOR
012318-1	PROJECT NUMBER
1/16"=1'-0"	SCALE
CL	DRAWN BY
	SHEET NUMBER

AB-1



© 2018 AEC CONSULTANTS INC

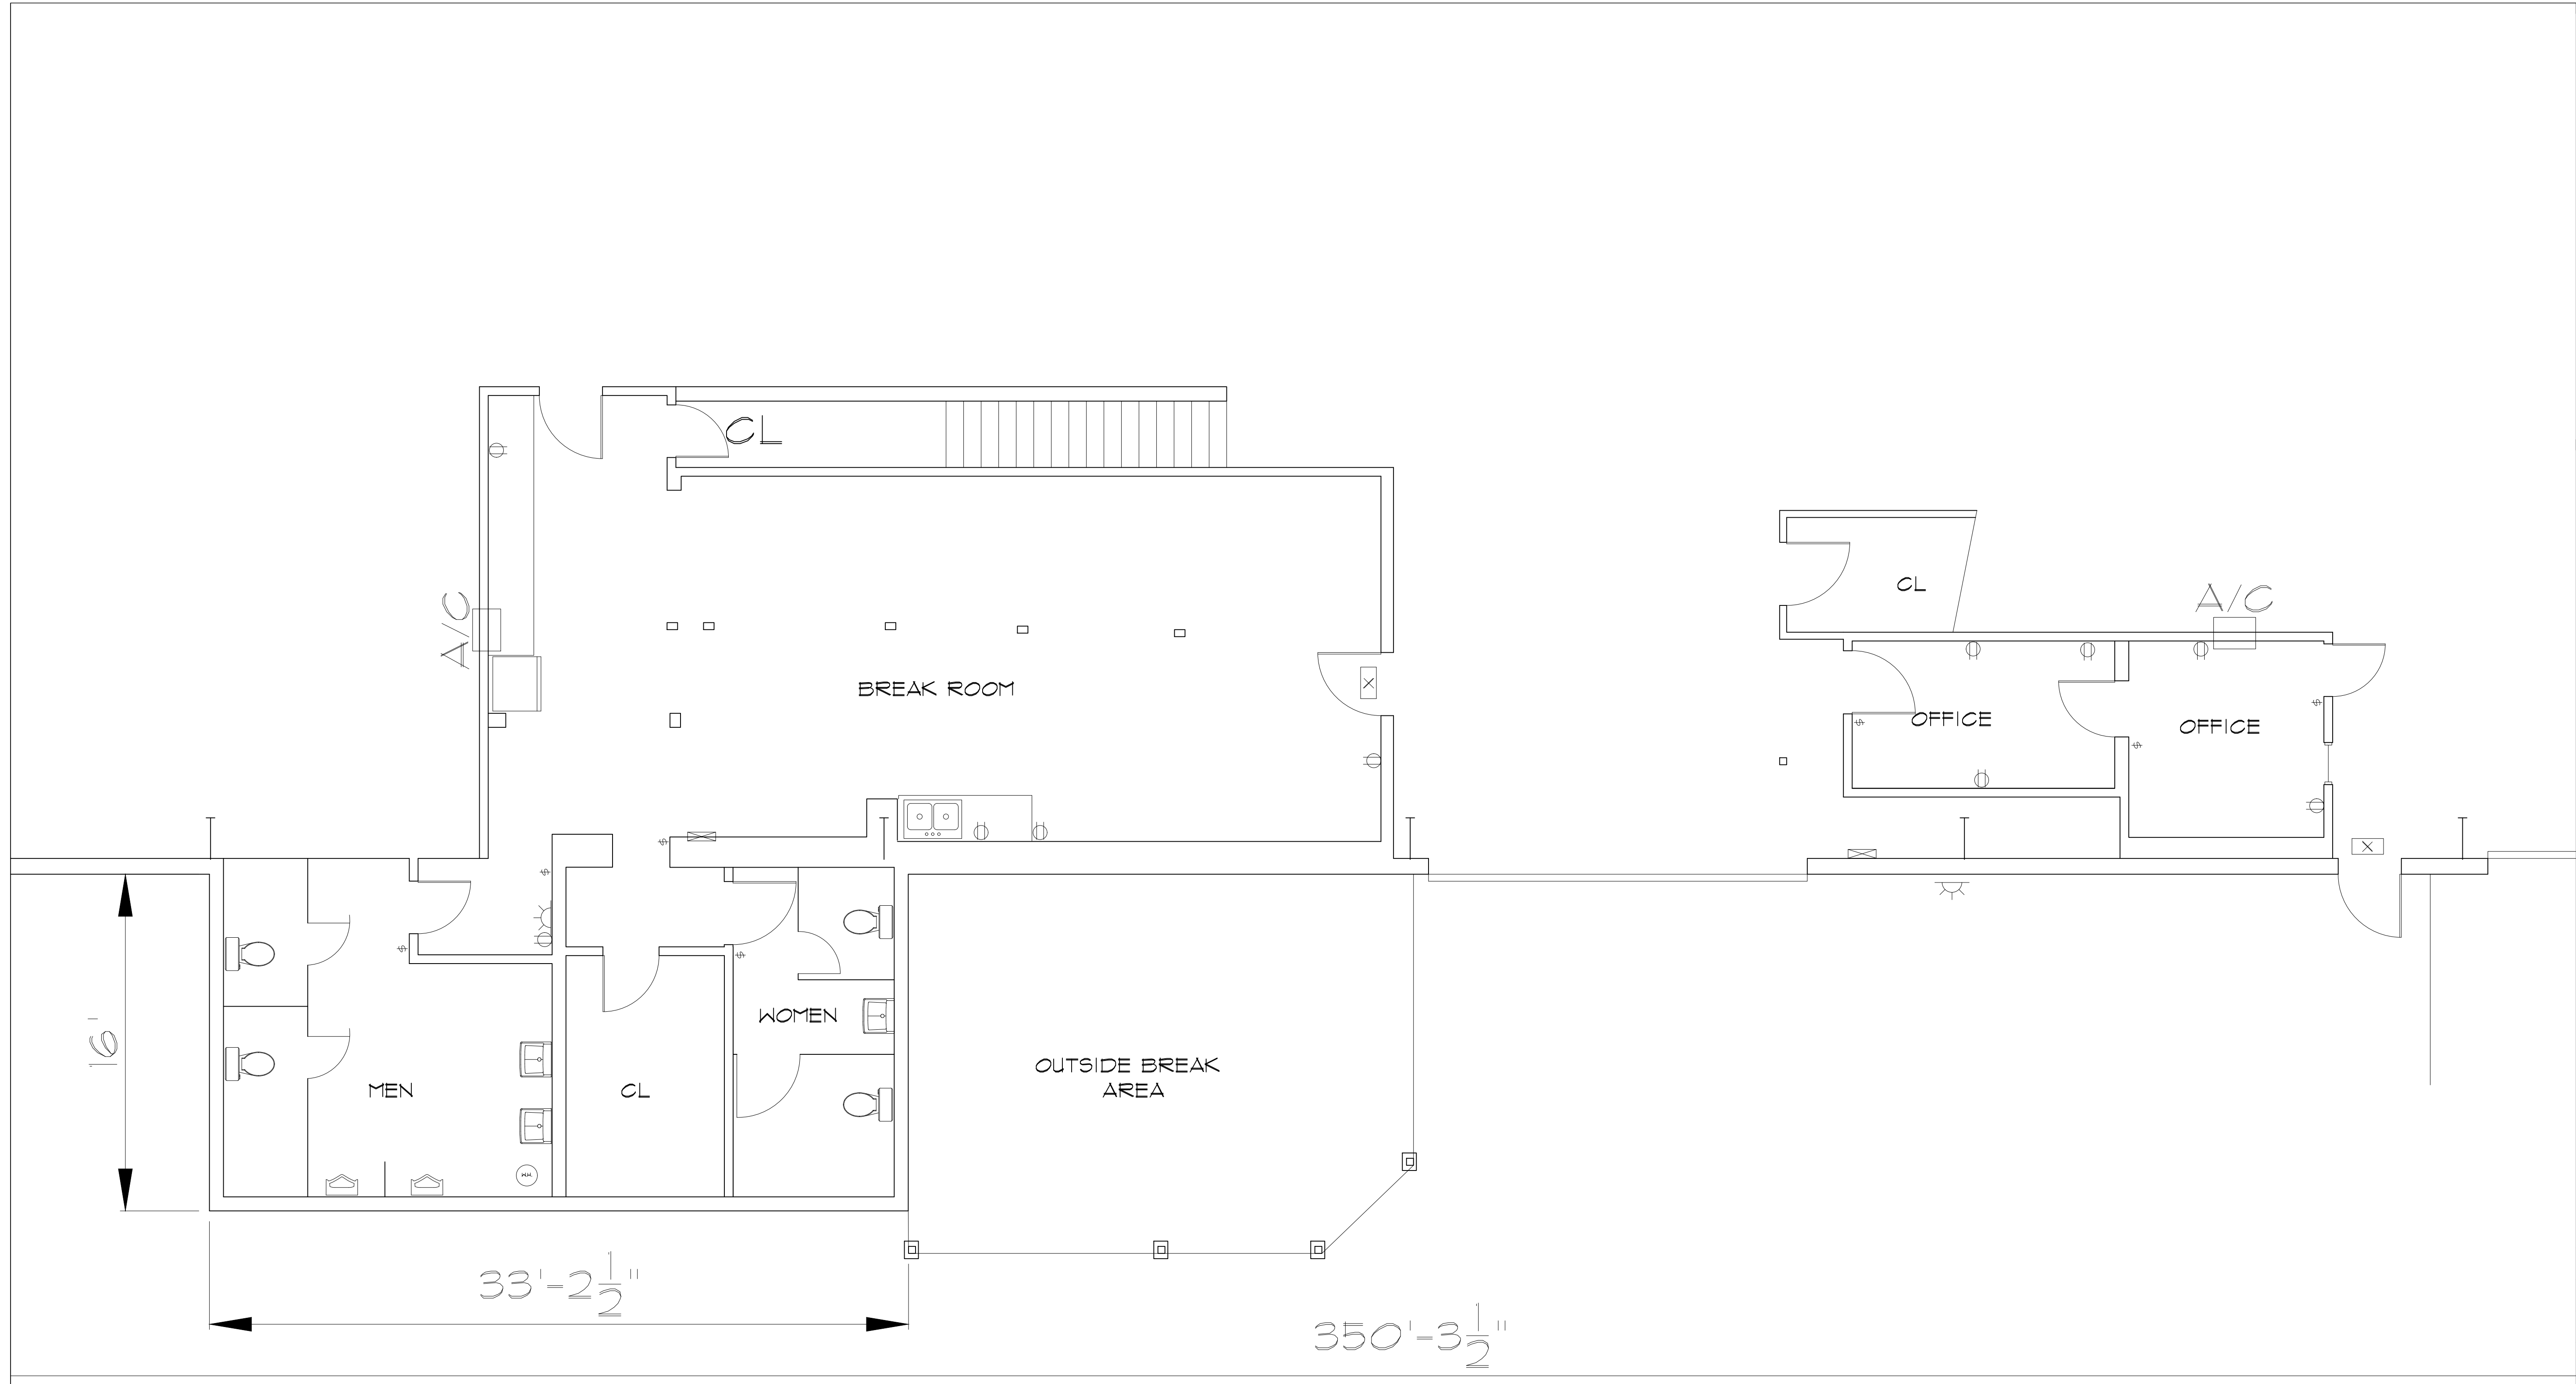



ARCHITECTURAL AS BUILT
LINCOLN LUMBER
 Union Point, GA 30669

01	100% SUBMISSION	SEE COVER SHEET
NO.	ISSUES REVISIONS	DATE

	PROJECT MANAGER
	PROJECT DIRECTOR
	PROJECT NUMBER
	SCALE
	DRAWN BY
	SHEET NUMBER

HL	PROJECT MANAGER
HL	PROJECT DIRECTOR
012318-1	PROJECT NUMBER
1/4"=1'-0"	SCALE
CL	DRAWN BY
	SHEET NUMBER

AB-2

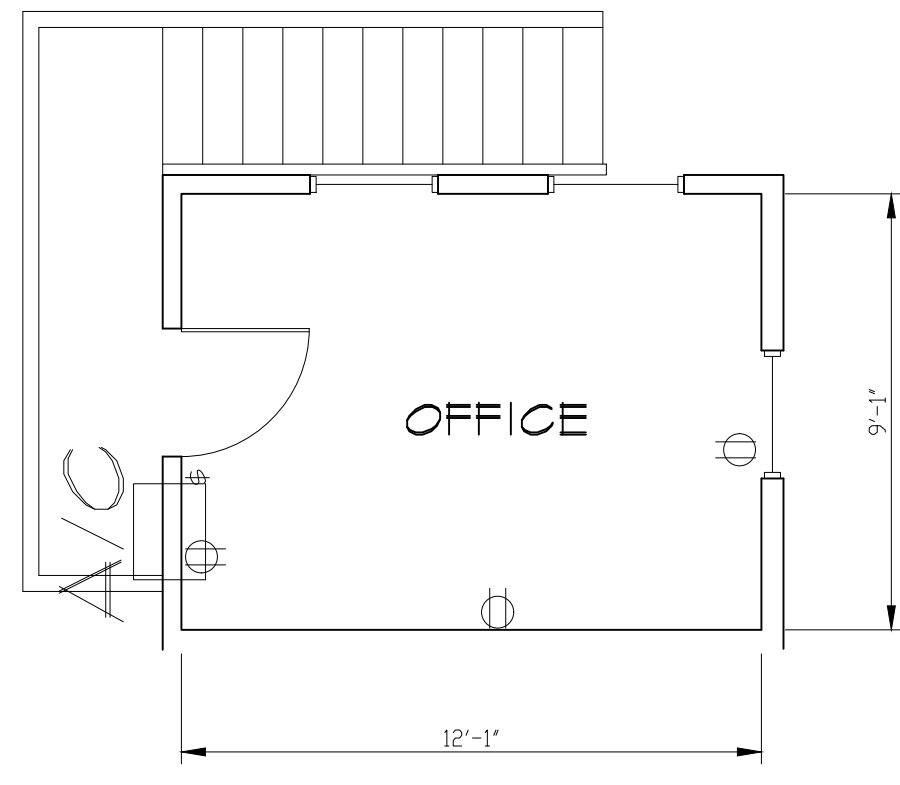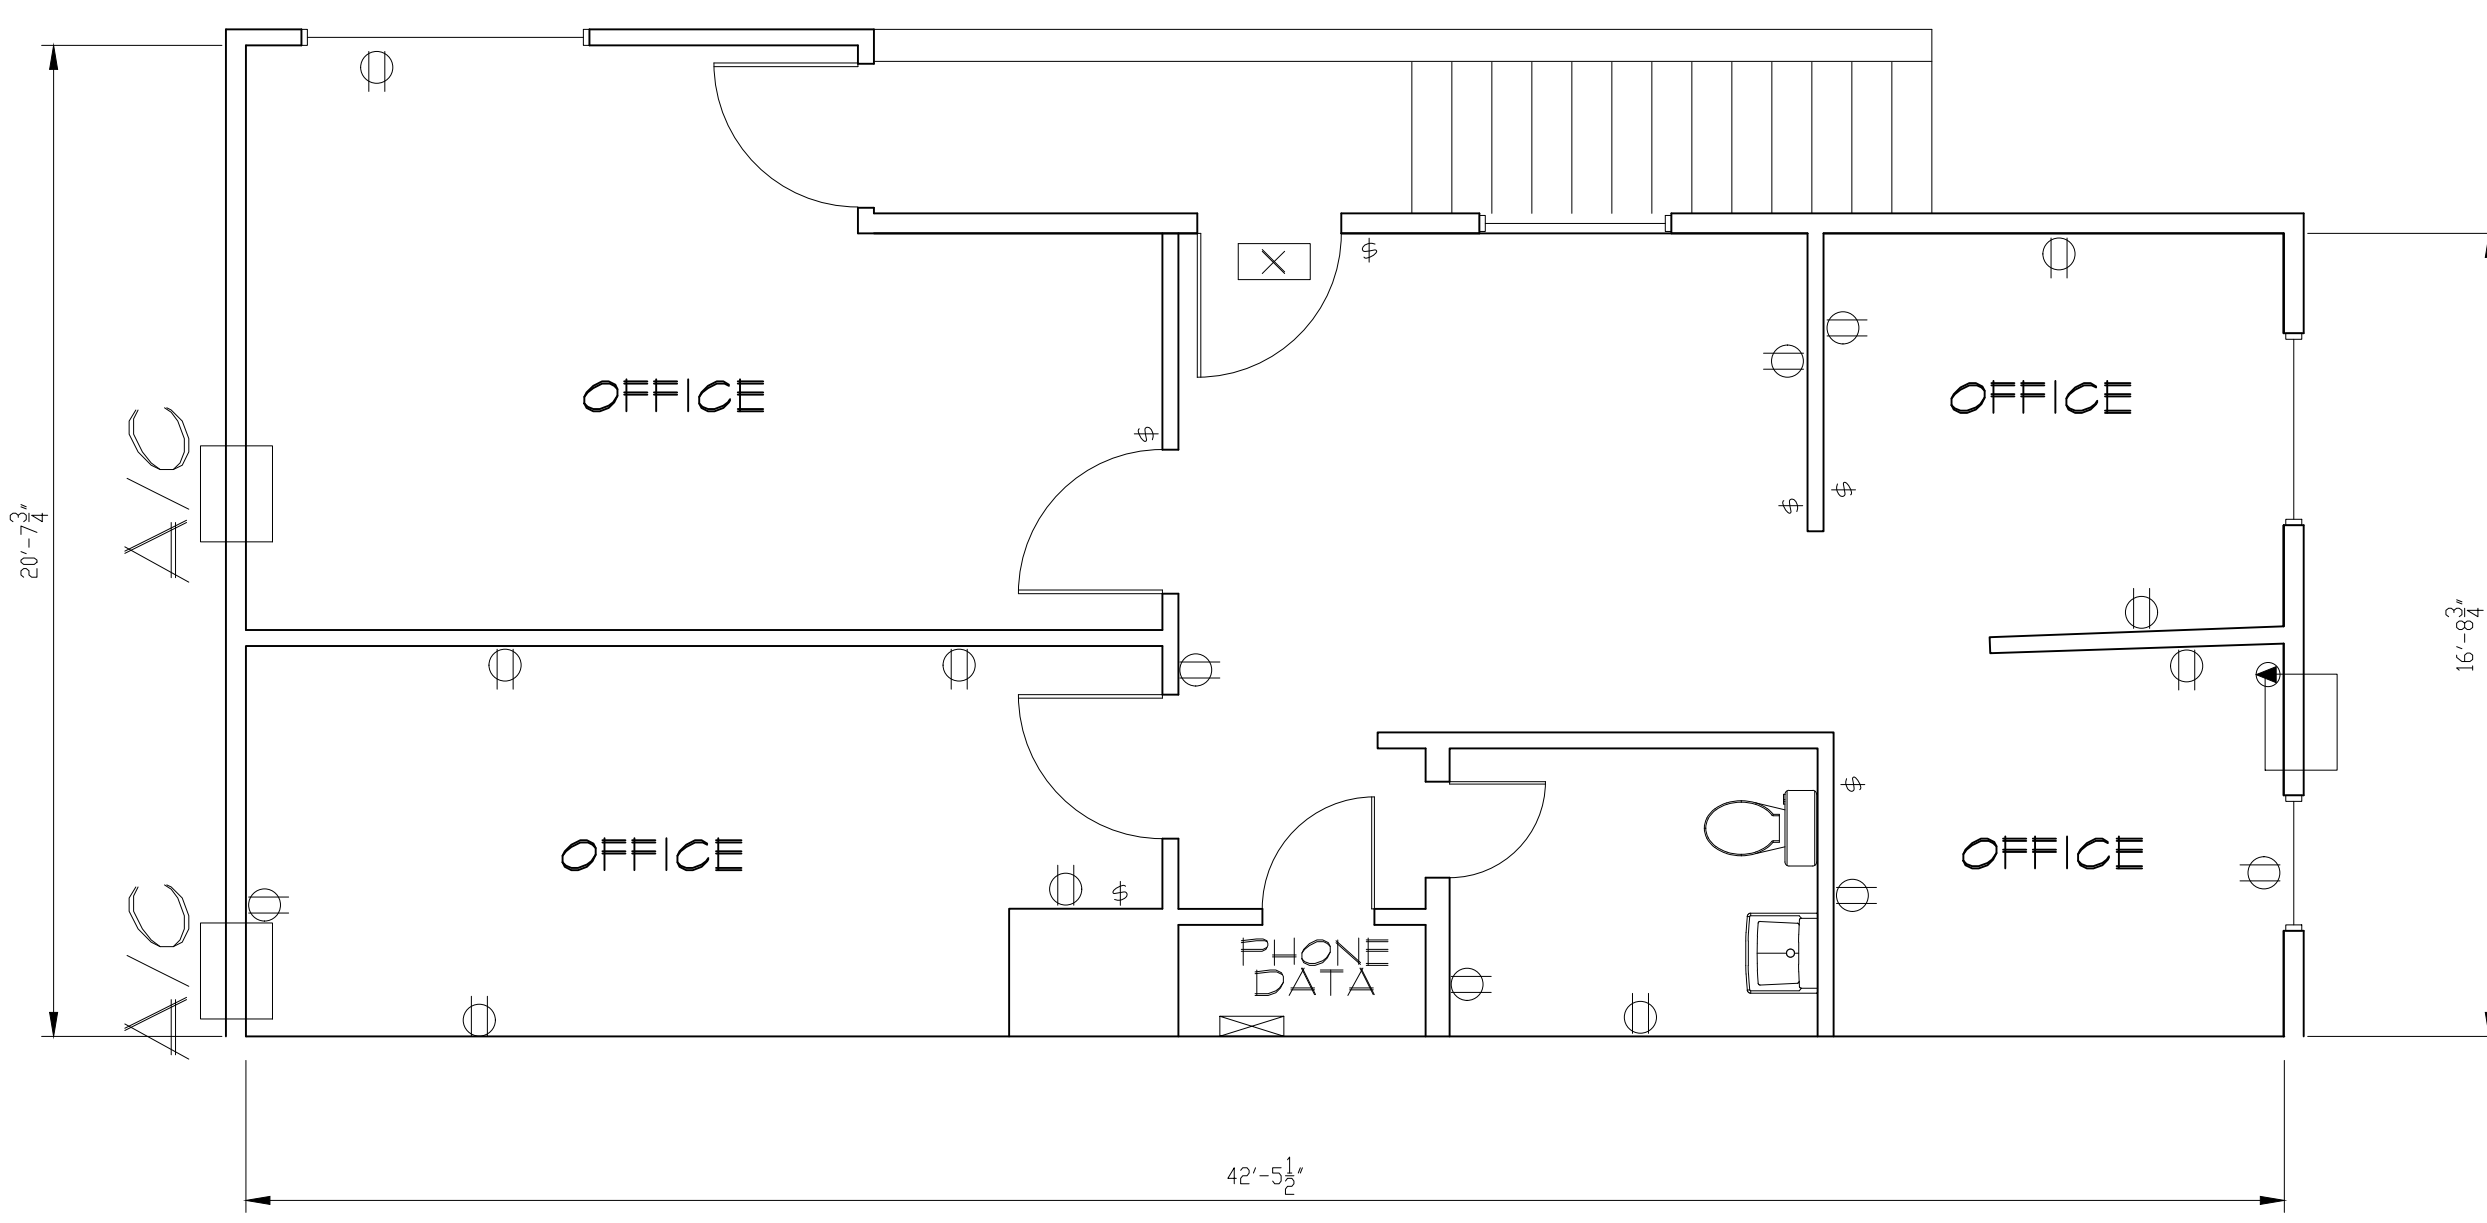

MEZZANINE

**ARCHITECTURAL AS BUILT
LINCOLN LUMBER**

- Union Point, GA 30669

01	100% SUBMISSION	SEE COVER SHEET
NO.	ISSUES REVISIONS	DATE

SHEET TITLE

HL	PROJECT MANAGER
HL	PROJECT DIRECTOR
012318-1	PROJECT NUMBER
1/4"=1'-0"	SCALE
CL	DRAWN BY
	SHEET NUMBER

AB-3