


ST. CHARLES, MO 63304



100% SUBMITTAL

DRAWING INDEX

C-1	COVER SHEET DRAWING INDEX
SL	SYMBOLS LEGEND
AB-1	OVER ALL REFLECTED CEILING PLAN $\frac{1}{32}"=1'-0"$
AB-2	REFLECTED CEILING PLAN $\frac{1}{8}"=1'-0"$
AB-3	REFLECTED CEILING PLAN $\frac{1}{8}"=1'-0"$
AB-4	REFLECTED CEILING PLAN $\frac{1}{8}"=1'-0"$
AB-5	REFLECTED CEILING PLAN $\frac{1}{8}"=1'-0"$
AB-6	REFLECTED CEILING PLAN $\frac{1}{8}"=1'-0"$
AB-7	REFLECTED CEILING PLAN $\frac{1}{8}"=1'-0"$
AB-8	REFLECTED CEILING PLAN $\frac{1}{8}"=1'-0"$
AB-9	REFLECTED CEILING PLAN $\frac{1}{8}"=1'-0"$
AB-10	REFLECTED CEILING PLAN $\frac{1}{8}"=1'-0"$

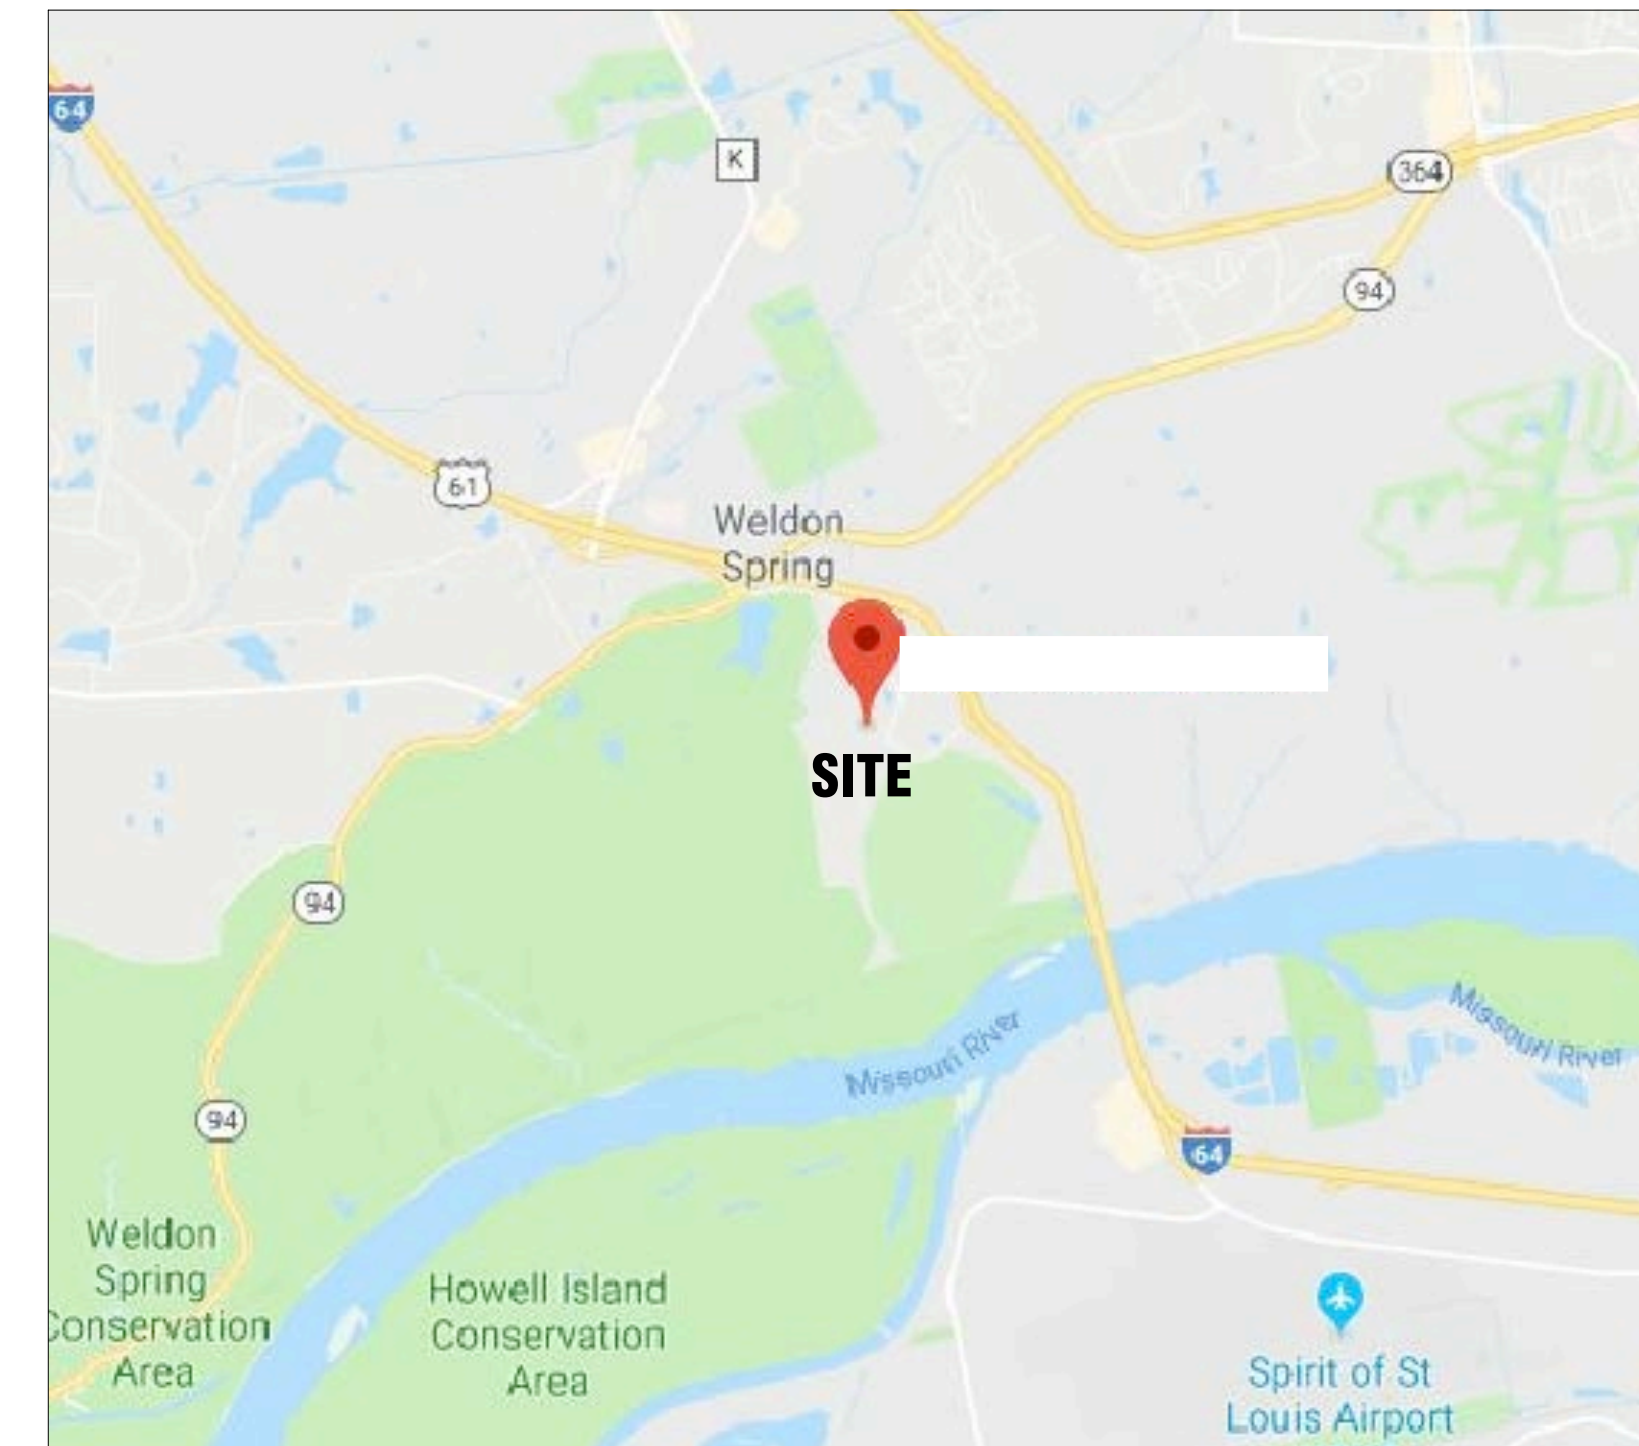

 **VICINITY MAP**
NTS

AS BUILT 
PROFESSIONALS
www.asbuiltprofessionals.com

A DIVISION OF:

AEC
 □
CONSULTANTS INC





844.272.8458
 844 AS BUILT






© 2018 AEC CONSULTANTS INC

**ARCHITECTURAL AS BUILT
NIKE MANUFACTURING
ST. CHARLES, MO**


01	100% SUBMISSION	SEE COVER SHEET
NO.	ISSUES REVISIONS	SCALE
		SHEET TITLE
COVER SHEET		
HL		PROJECT MANAGER
HL		PROJECT DIRECTOR
012317-1		PROJECT NUMBER
		SCALE
MM		DRAWN BY
		SHEET NUMBER
C-1		

    LEGEND

   -  EXHAUST VENT
-  CEILING MOUNTED LIGHT FIXTURE
-  CEILING MOUNTED DIRECTIONAL LIGHT
-  RECESSED CAN LIGHT
-  EYEBALL OR SMALL CAN LIGHT
-  PENDANT LIGHT
-  INDIVIDUAL FLUOR. LAY-IN FIXTURE 4 BULB
-  INDIVIDUAL FLUOR. HANGING FIXTURE 2 BULB
-  INDIVIDUAL FLUOR. FLUSH MOUNT FIXTURE 4 BULB
- CAMERA
-  MOTION DET.
-  SUPPLY VENT
-  SUPPLY VENT
-  RETURN VENT
-  RETURN VENT
-  SPEAKER

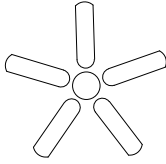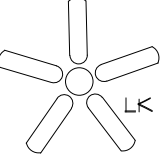-  TRACK LIGHT OR VANITY LIGHT
-  WALL-MOUNTED LIGHT FIXTURE
-  EMERGENCY EXIT SIGN
-  EMERGENCY EXIT LIGHT
-  EMERGENCY EXIT LIGHT W/ SIGN
-  LIGHTED STAIR SIGN
-  FLOOD LIGHT
-  PHOTO CELL
-  CEILING FAN
-  CEILING FAN W/ LIGHT KIT
- 7-2-6

 
CEILING HEIGHT AND TRIM 7'-2" ABOVE FLOOR BELOW WITH 6" CROWN MOULDING. NOTE: ALL CEILINGS NOT LABELED ARE PLASTER. CEILINGS SHOWN WITH A GRID ARE LAY IN ACOUSTICAL TILE..
-  JUNCTION BOX

-  DATA OUTLET
-  TELEPHONE JACK
-  ELECTRIC SWITCH
-  CABLE TELEVISION OUTLET
-  DUPLEX RECEPTACLE OUTLET
-  SPECIAL PURPOSE CONNECTION OR OUTLET
-  QUADRUPLIX RECEPTACLE OUTLET
-  FLOOR DUPLEX RECEPTACLE OUTLET
-  ELECTRIC PANEL
-  ELECTRIC METER
-  BUTTON SWITCH
-  DISCONNECT SWITCH
-  GROUND/FLOOR LIGHT
-  KEY PAD


-  FIRE EXTINGUISHER
-  FIRE PULL
-  FIRE ALARM (HORN/STROBE)
-  SMOKE DETECTOR
-  SMOKE ALARM SPEAKER
-  SPRINKLER HEAD CEILING MOUNT
-  SPRINKLER HEAD WALL MOUNT

-  THERMOSTAT
-  FLOOR DRAIN
-  VALVE
-  HOSE BIB
-  WATER SUPPLY
-  SUSPENDEG GAS HEATER


-  BOLLARD
-  11-4-11/16 SPOT ELEVATION

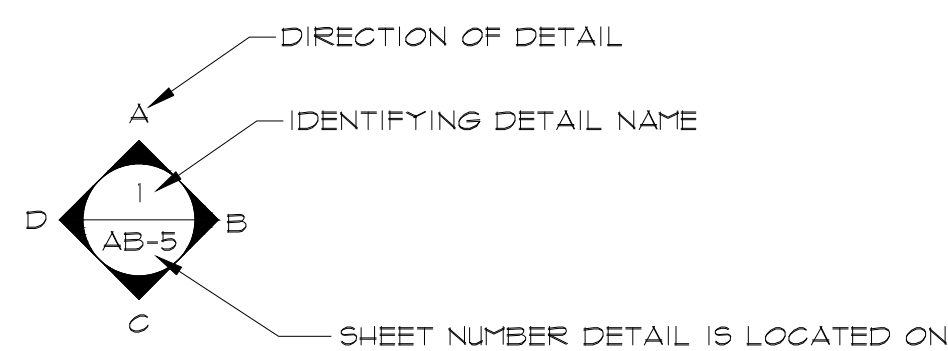

INTERIOR ELEVATIONS

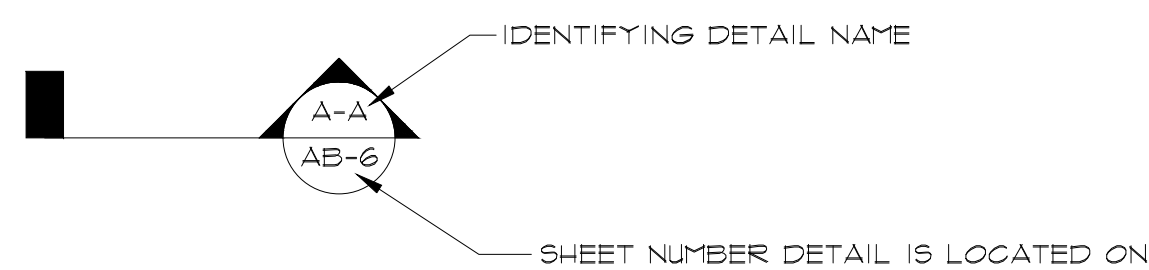

BUILDING SECTION

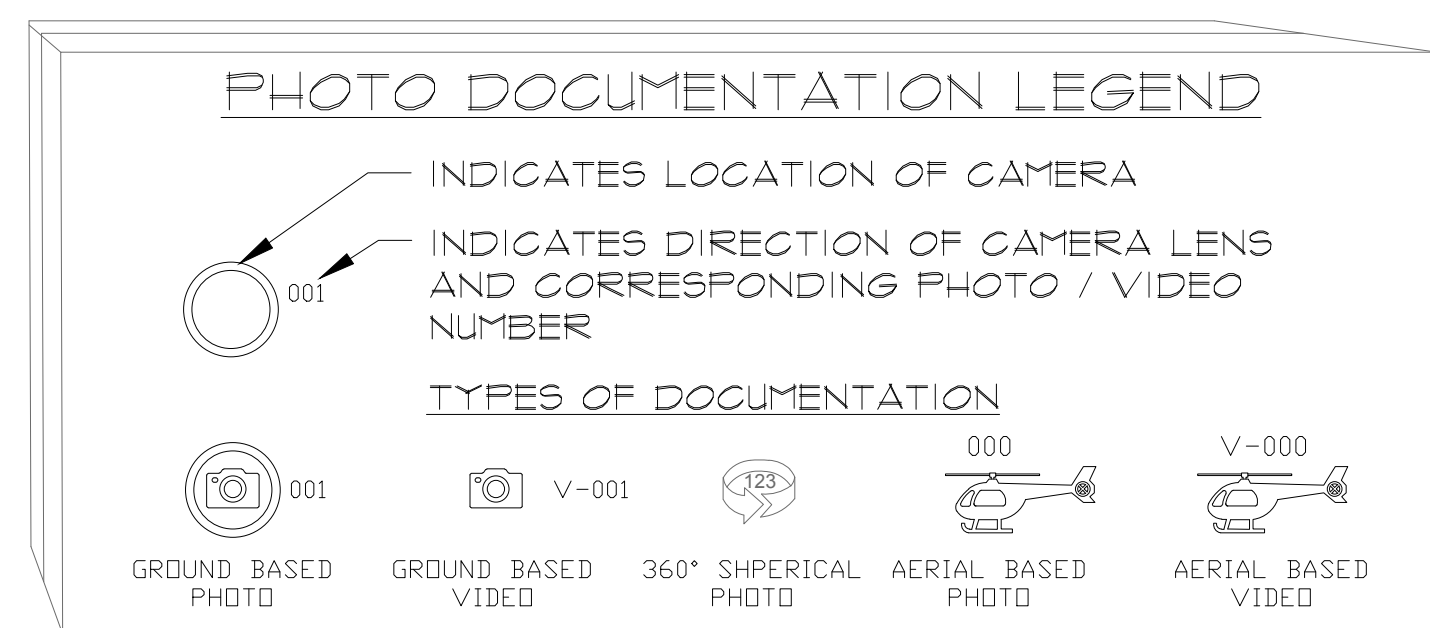

LINE LEGEND


- UTILITY-COMPRESSED AIR
- UTILITY-WATER-SUPPLY
- UTILITY-WATER-TOWER
- BUSWAY
- DISPLAY-BOARD



ARCHITECTURAL AS BUILT
NIKE MANUFACTURING
ST. CHARLES, MO

01	100% SUBMISSION	SEE COVER SHEET
NO.	ISSUES REVISIONS	DATE
		SHEET TITLE
SHEET LEGEND		
HL	PROJECT MANAGER	
HL	PROJECT DIRECTOR	
012317-1	PROJECT NUMBER	
NOT TO SCALE		SCALE
MM	DRAWN BY	
		SHEET NUMBER

SL

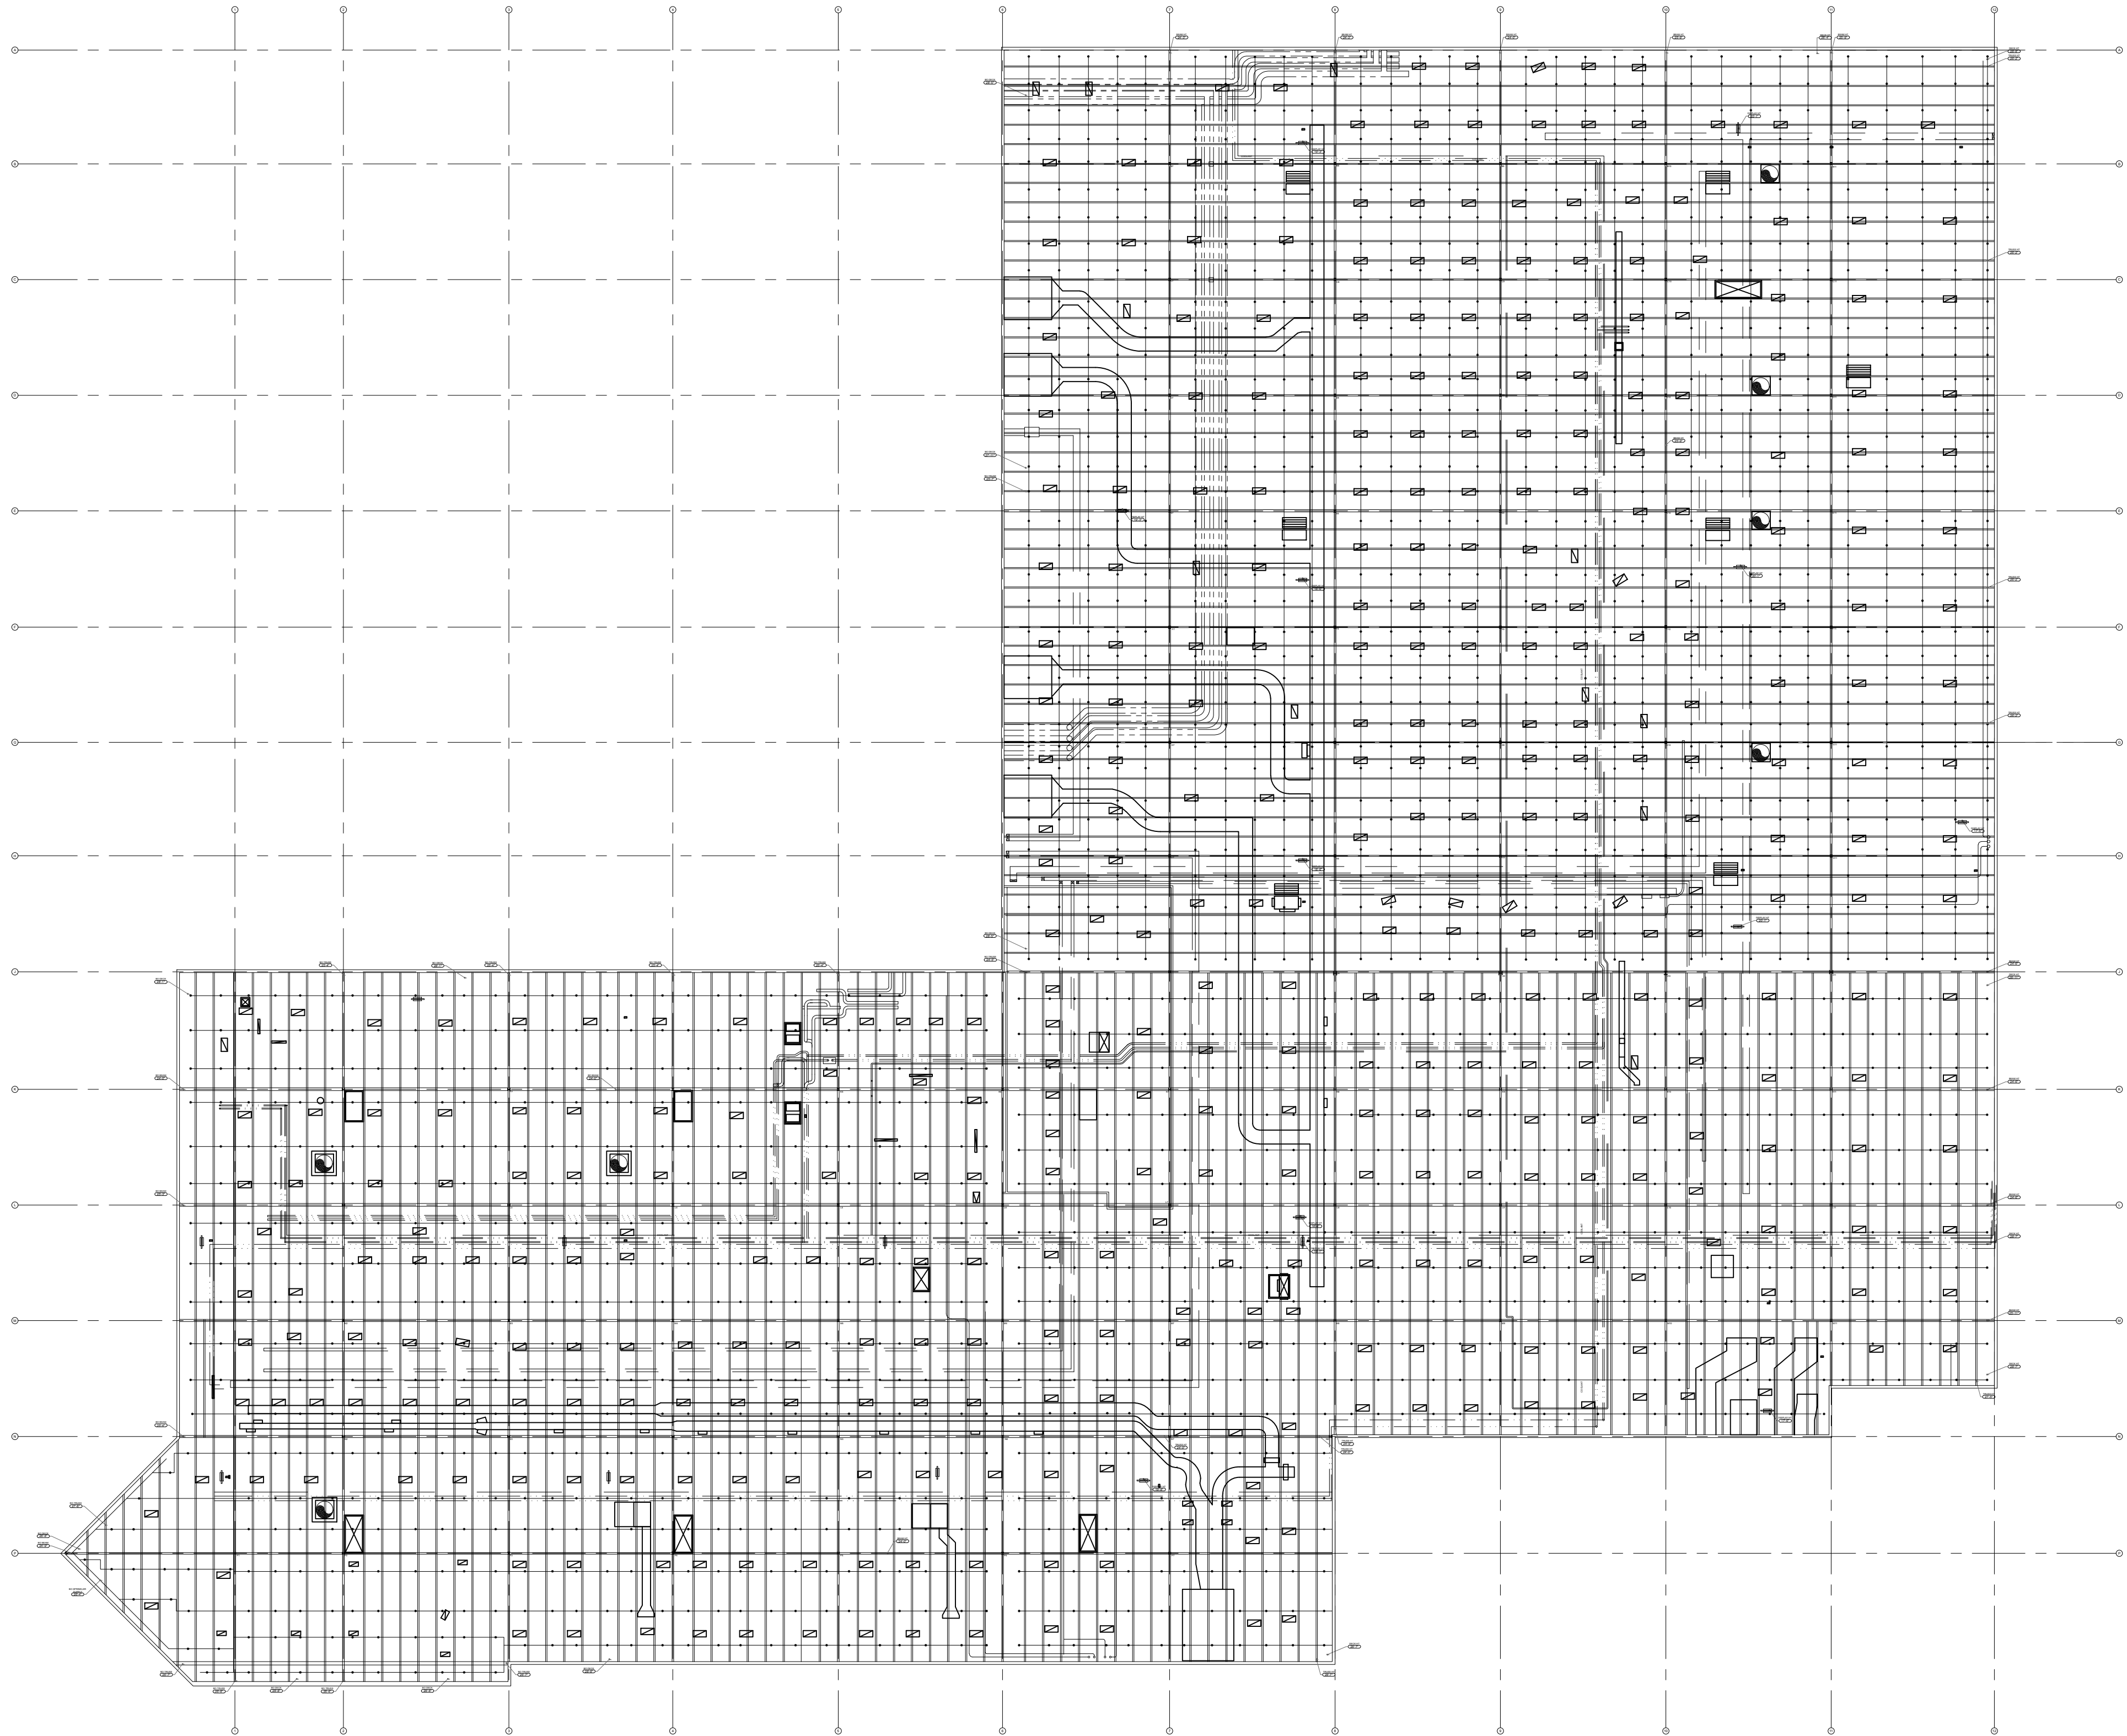

© 2019 AEC CONSULTANTS INC

ARCHITECTURAL AS BUILT
NIKE MANUFACTURING
ST. CHARLES, MO

01	100% SUBMISSION	SEE COVER SHEET
NO.	ISSUES REVISIONS	DATE

SHEET TITLE

REFLECTED CEILING PLAN

HL	PROJECT MANAGER
HL	PROJECT DIRECTOR
012317-1	PROJECT NUMBER
1/32"=1'-0"	SCALE
MM	DRAWN BY
	SHEET NUMBER

AB-1




**ARCHITECTURAL AS BUILT
NIKE MANUFACTURING
ST. CHARLES, MO**


01	100% SUBMISSION	SEE COVER SHEET
NO.	ISSUES REVISIONS	DATE
		SHEET TITLE
PARTIAL REFLECTED CEILING PLAN		
HL	PROJECT MANAGER	
HL	PROJECT DIRECTOR	
012317-1	PROJECT NUMBER	
1/8"=1'-0"		SCALE
MM	DRAWN BY	
		SHEET NUMBER

AB-2



AB-3

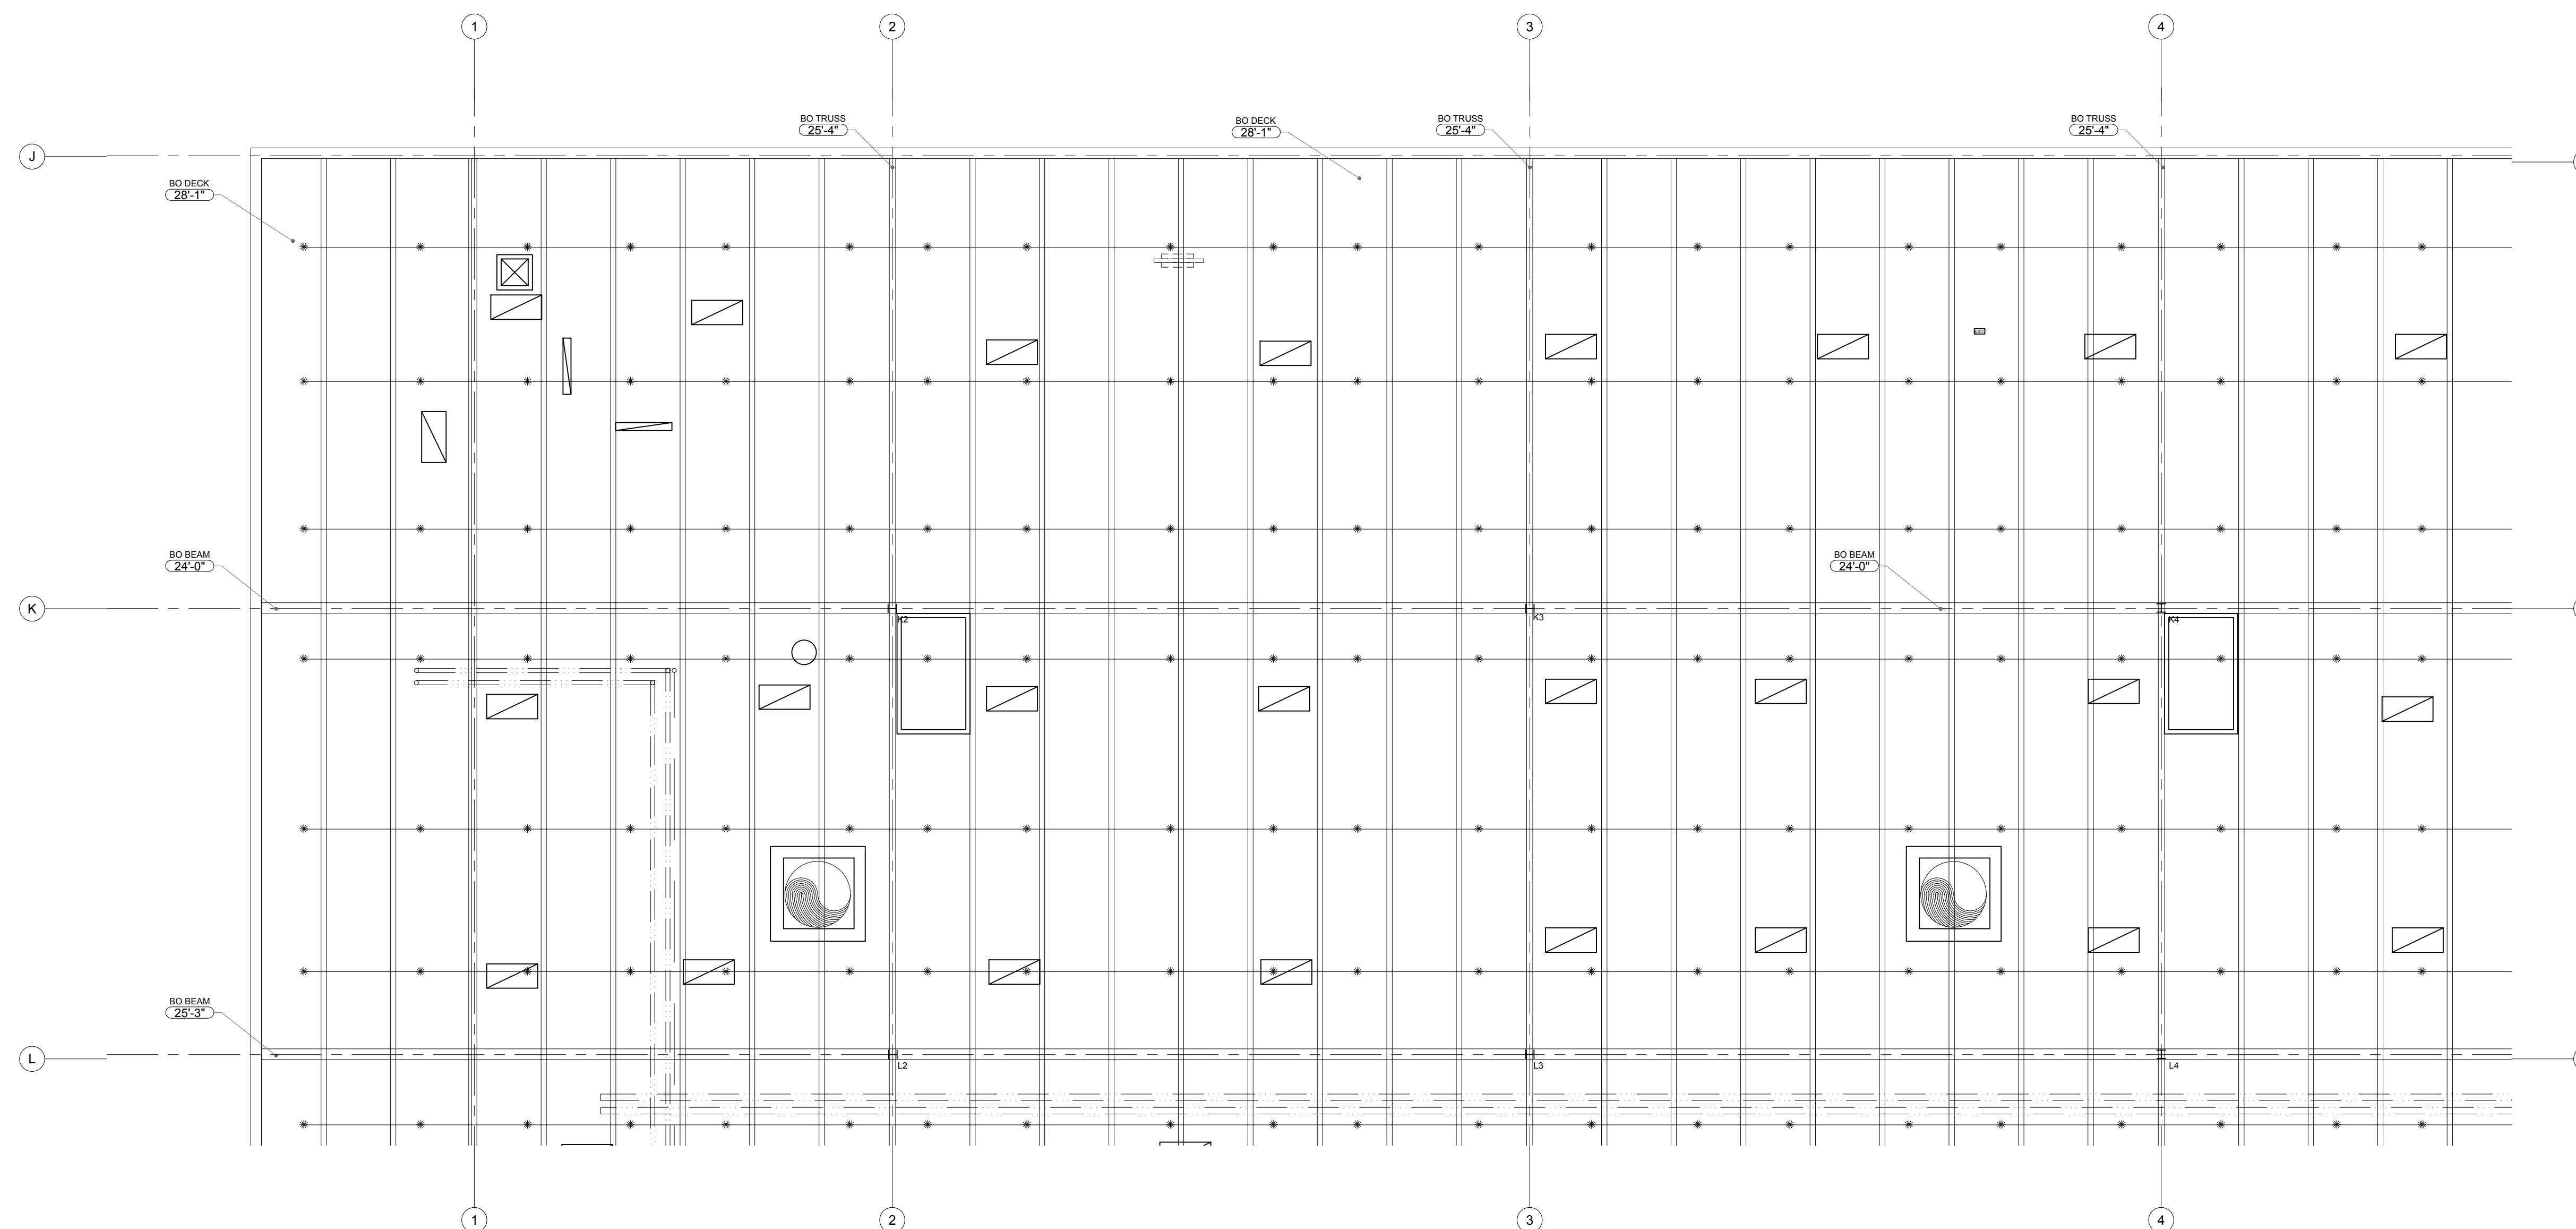

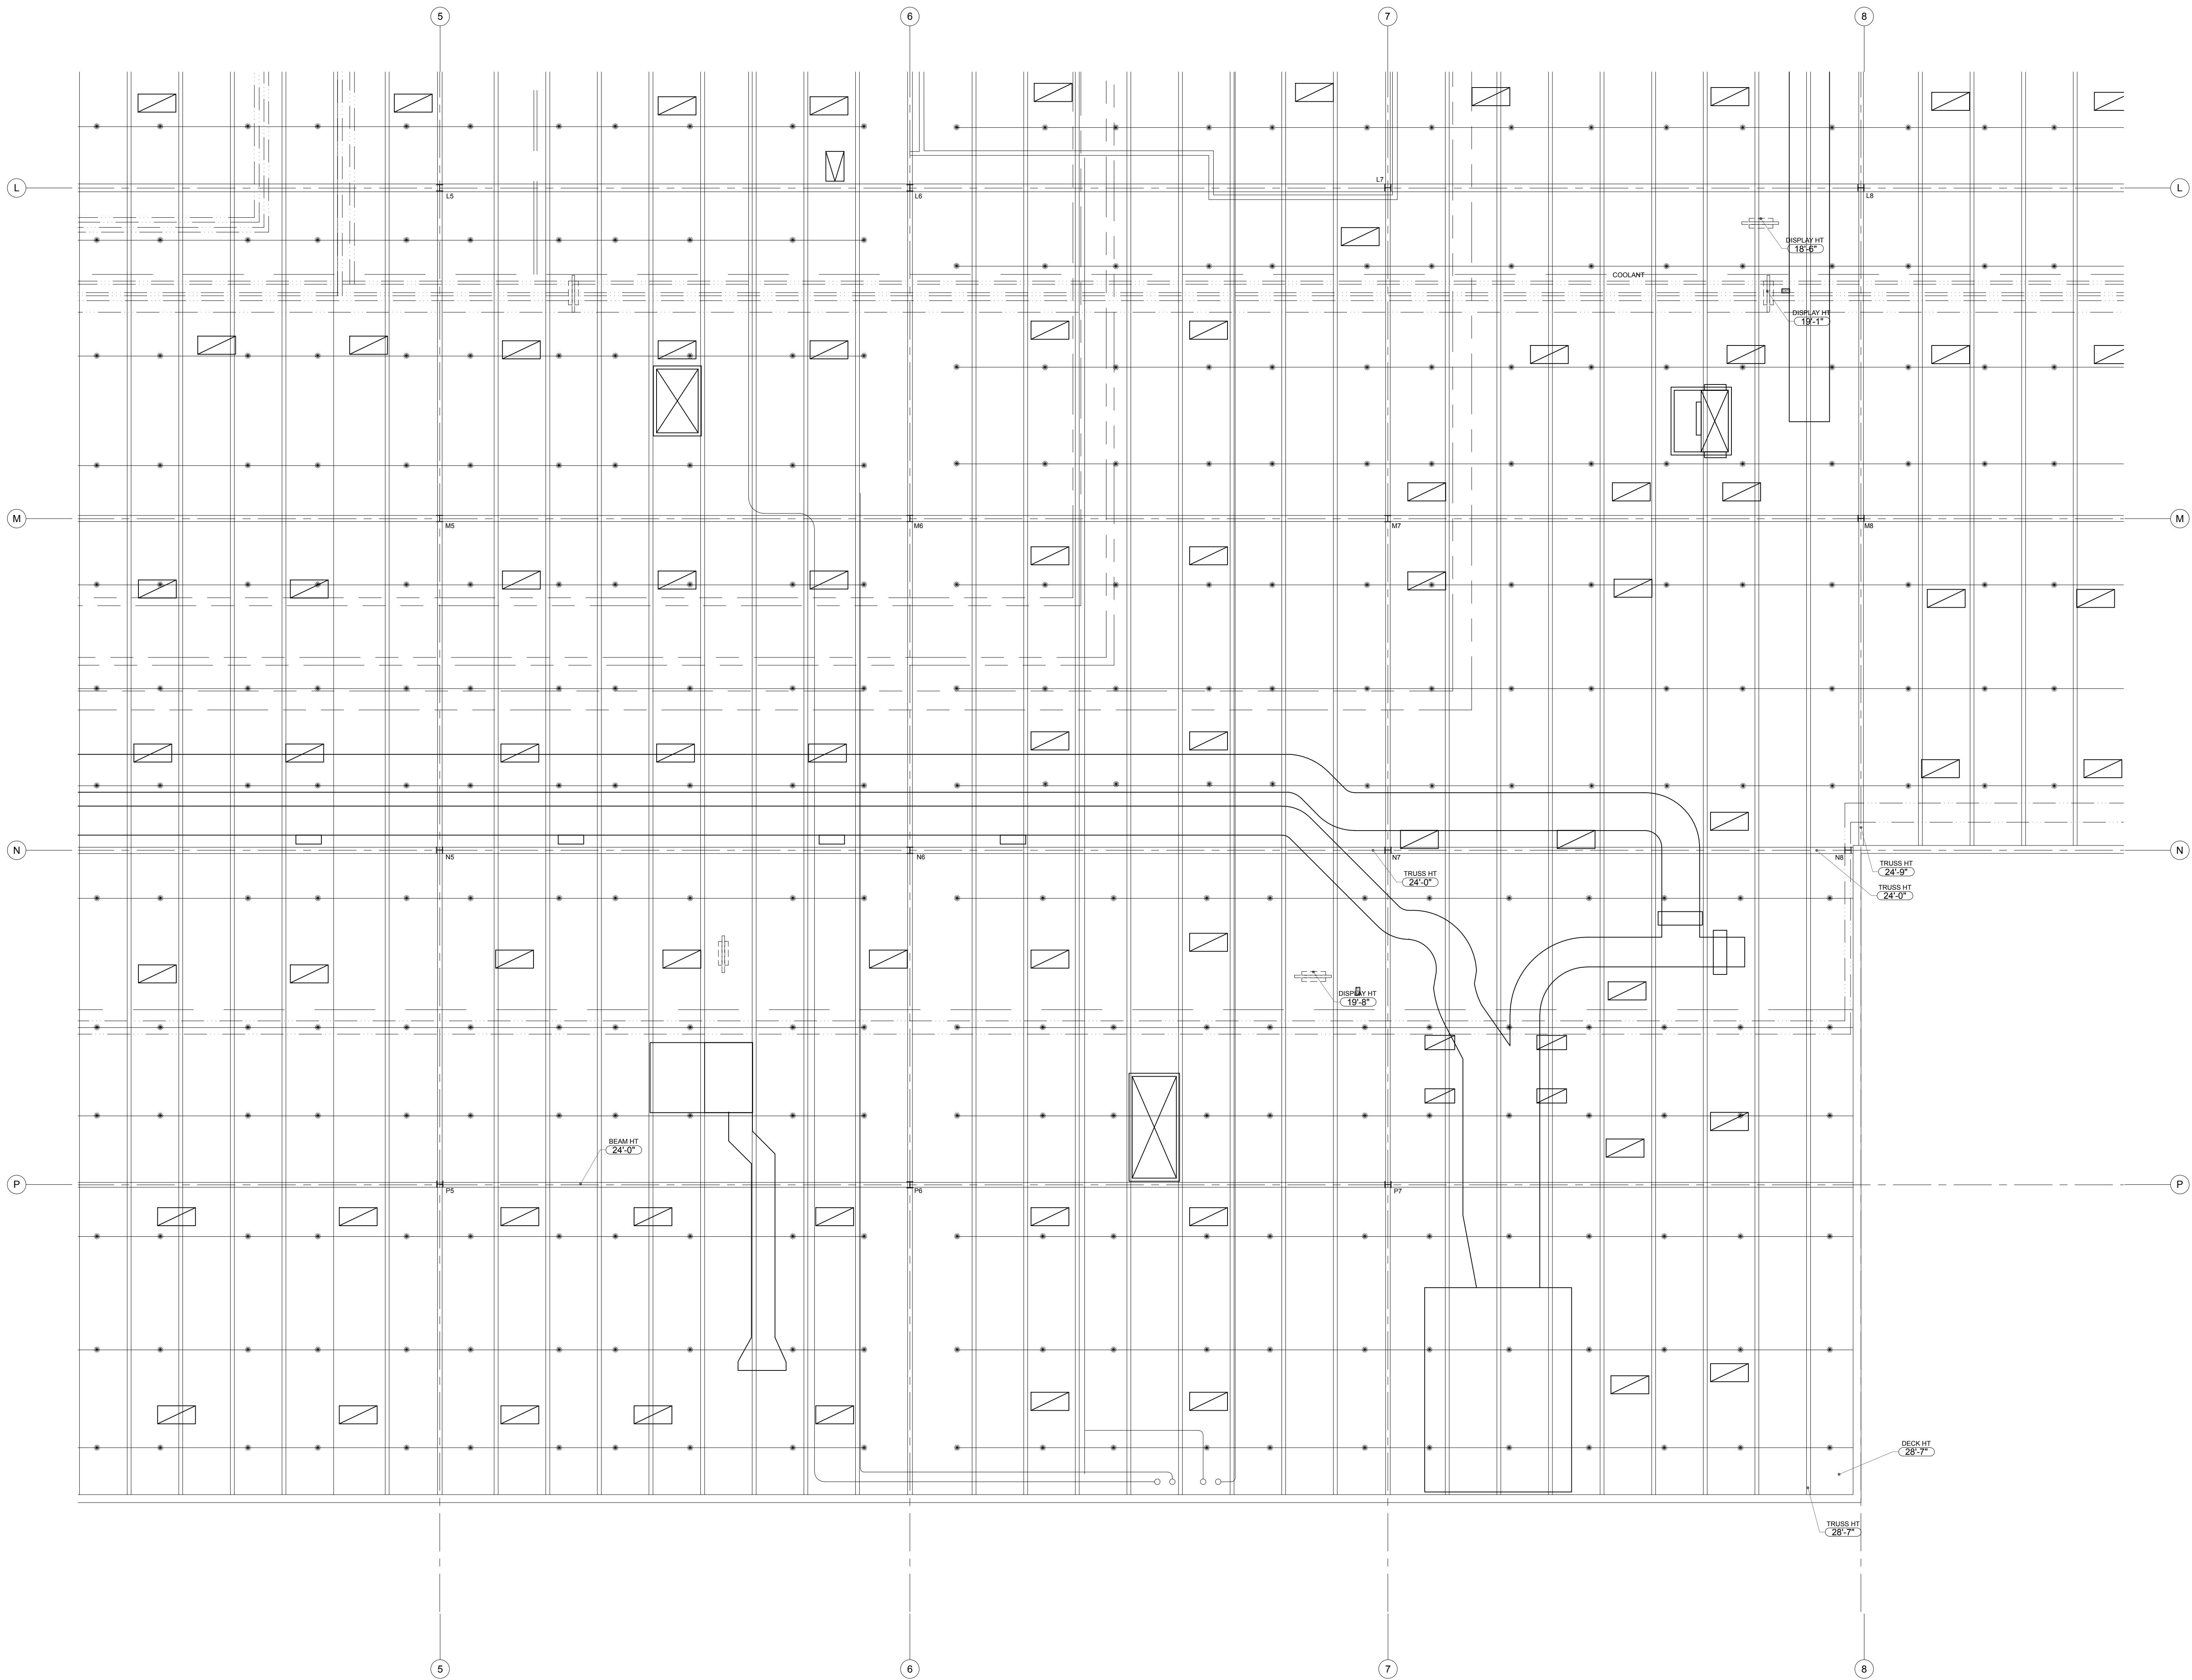

AS BUILT
PROFESSIONALS
www.asbuiltprofessionals.com
A DIVISION OF:

AEC
CONSULTANTS INC

844.272.8458
844 AS BUILT

© 2019 AEC CONSULTANTS INC


ARCHITECTURAL AS BUILT
NIKE MANUFACTURING
ST. CHARLES, MO

01	100% SUBMISSION	SEE COVER SHEET
NO.	ISSUES REVISIONS	DATE
SHEET TITLE		

PARTIAL
REFLECTED CEILING PLAN

HL	PROJECT MANAGER
HL	PROJECT DIRECTOR
012317-1	PROJECT NUMBER
1/8"=1'-0"	SCALE
MM	DRAWN BY
SHEET NUMBER	

AB-4

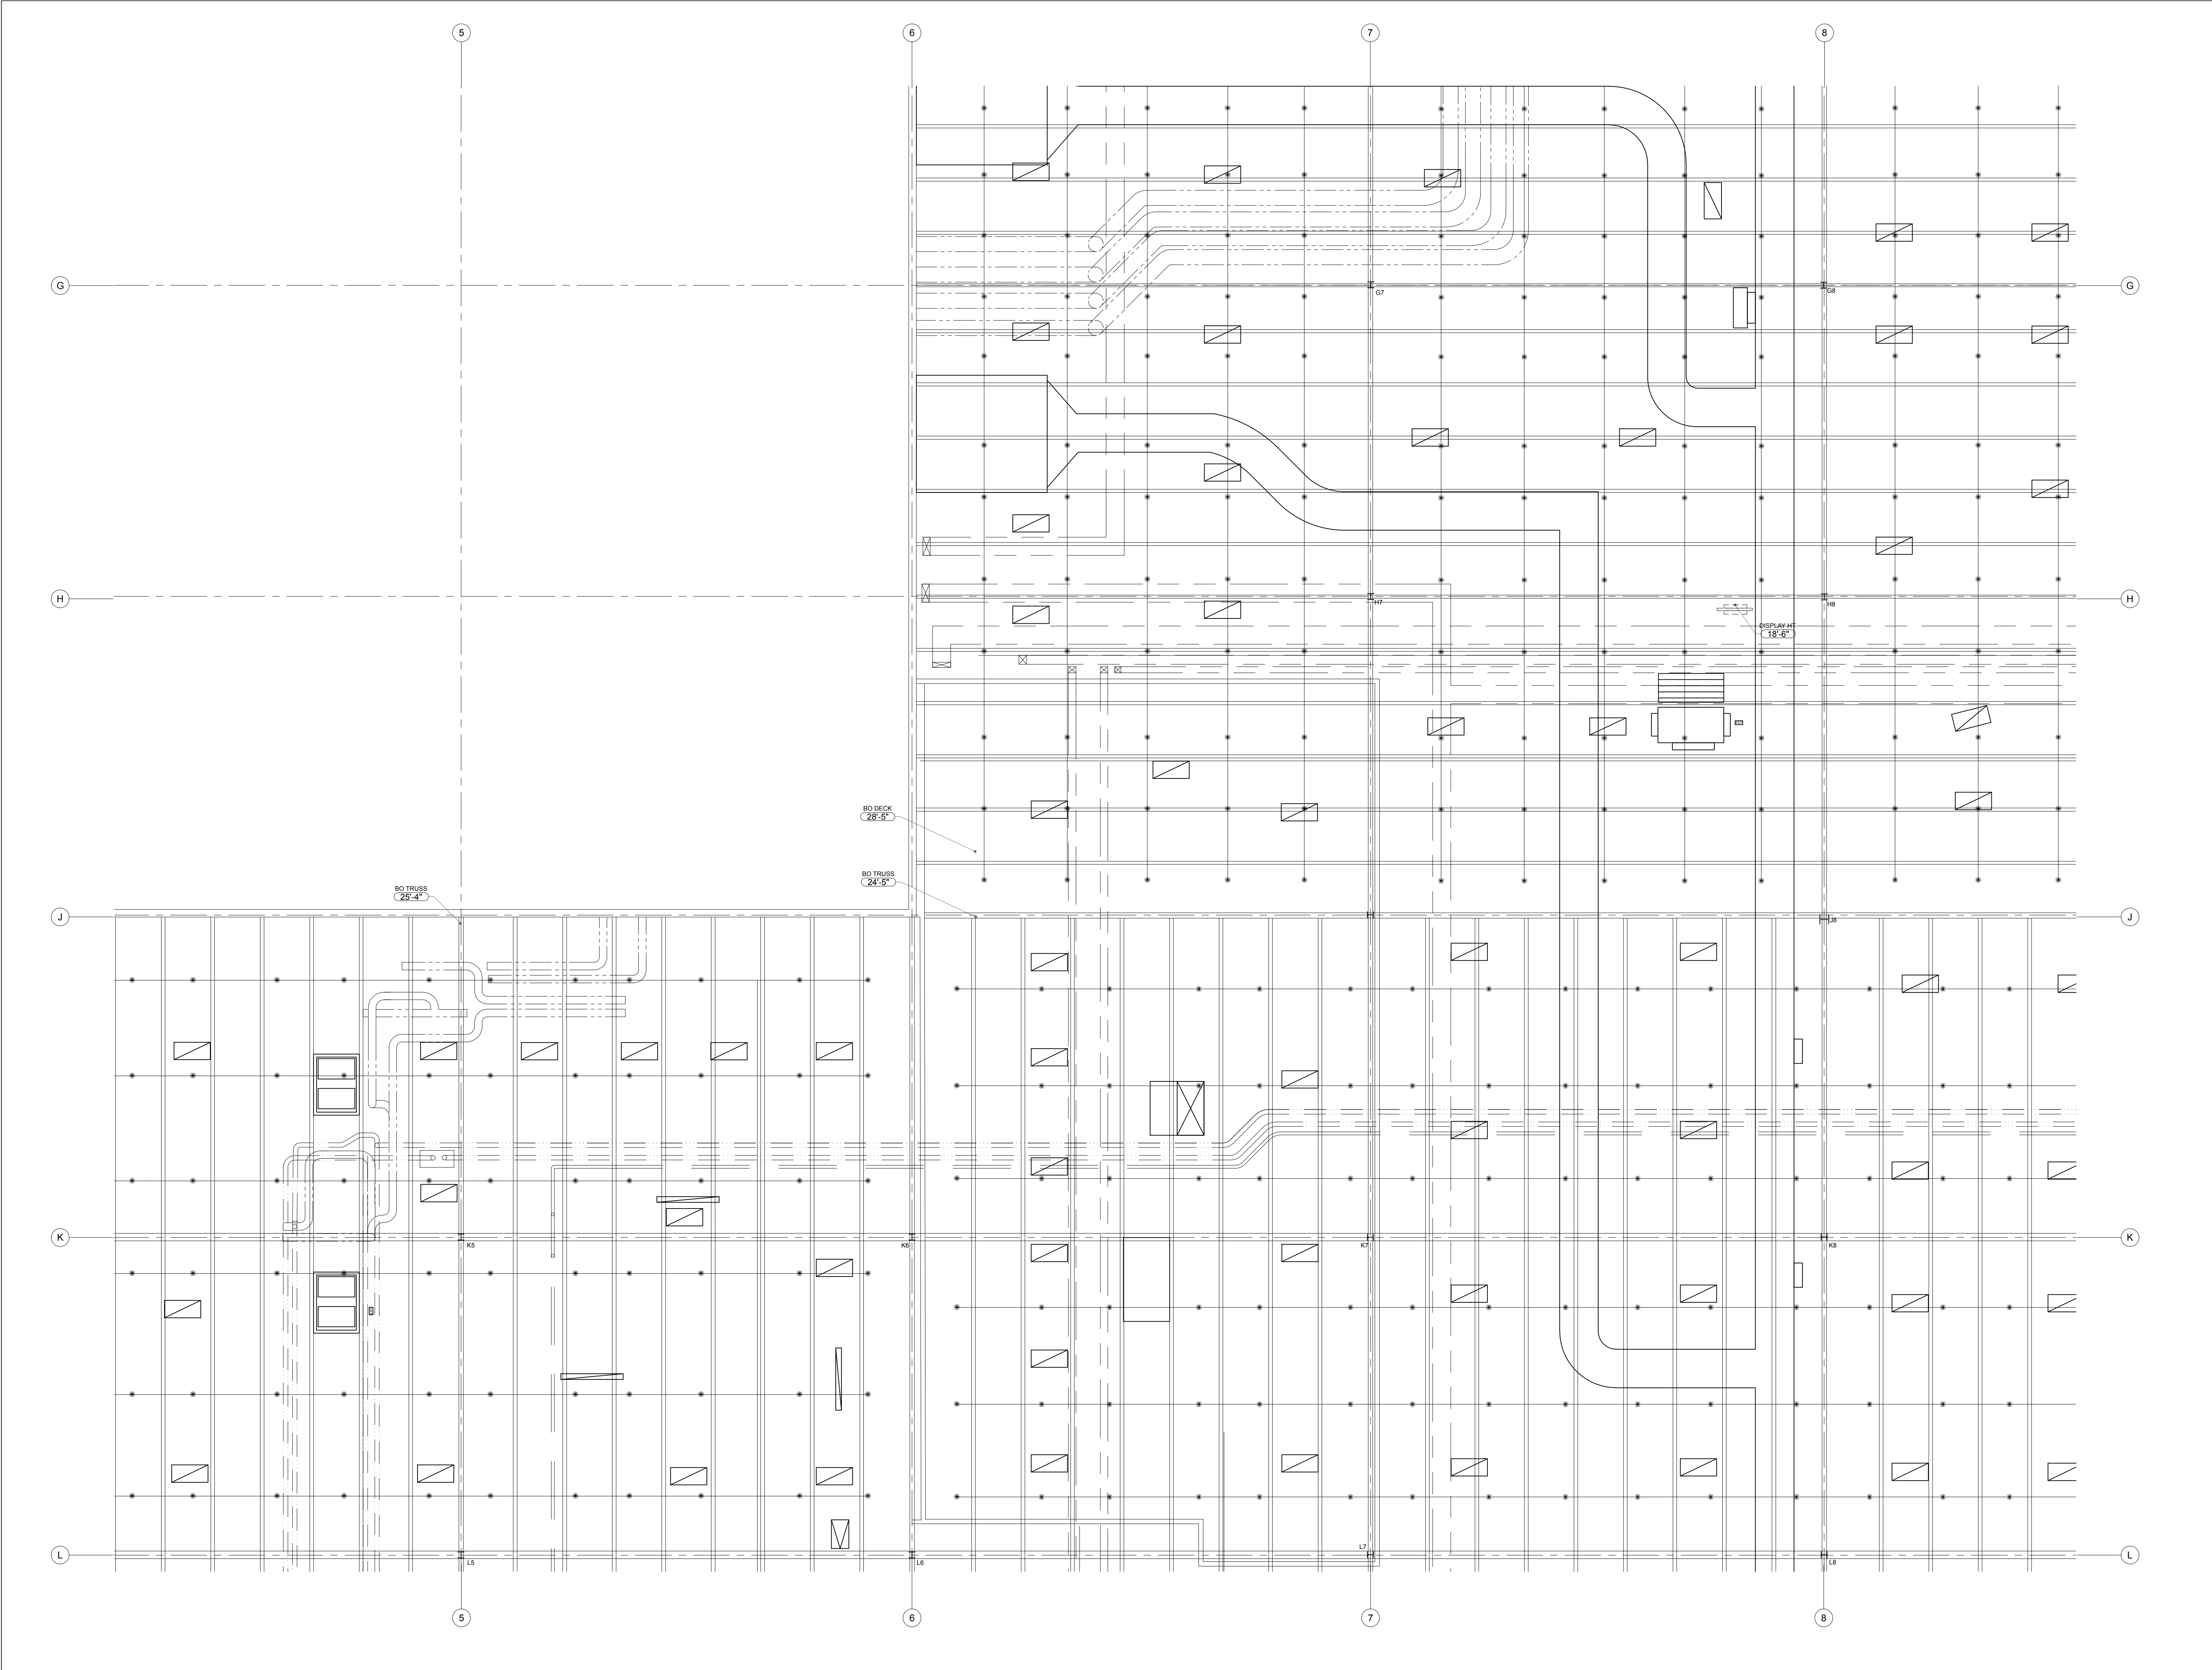

As BUILT

PROFESSIONALS

www.asbuiltprofessionals.com

A DIVISION OF:

AEC

CONSULTANTS INC

844.272.8458

844 AS BUILT

© 2019 AEC CONSULTANTS INC


ARCHITECTURAL AS BUILT

NIKE MANUFACTURING

ST. CHARLES, MO

01	100% SUBMISSION	SEE COVER SHEET
NO.	ISSUES REVISIONS	DATE
SHEET TITLE		
PARTIAL REFLECTED CEILING PLAN		
HL	PROJECT MANAGER	
HL	PROJECT DIRECTOR	
012317-1	PROJECT NUMBER	
1/8"=1'-0"	SCALE	
MM	DRAWN BY	
	SHEET NUMBER	

AB-5

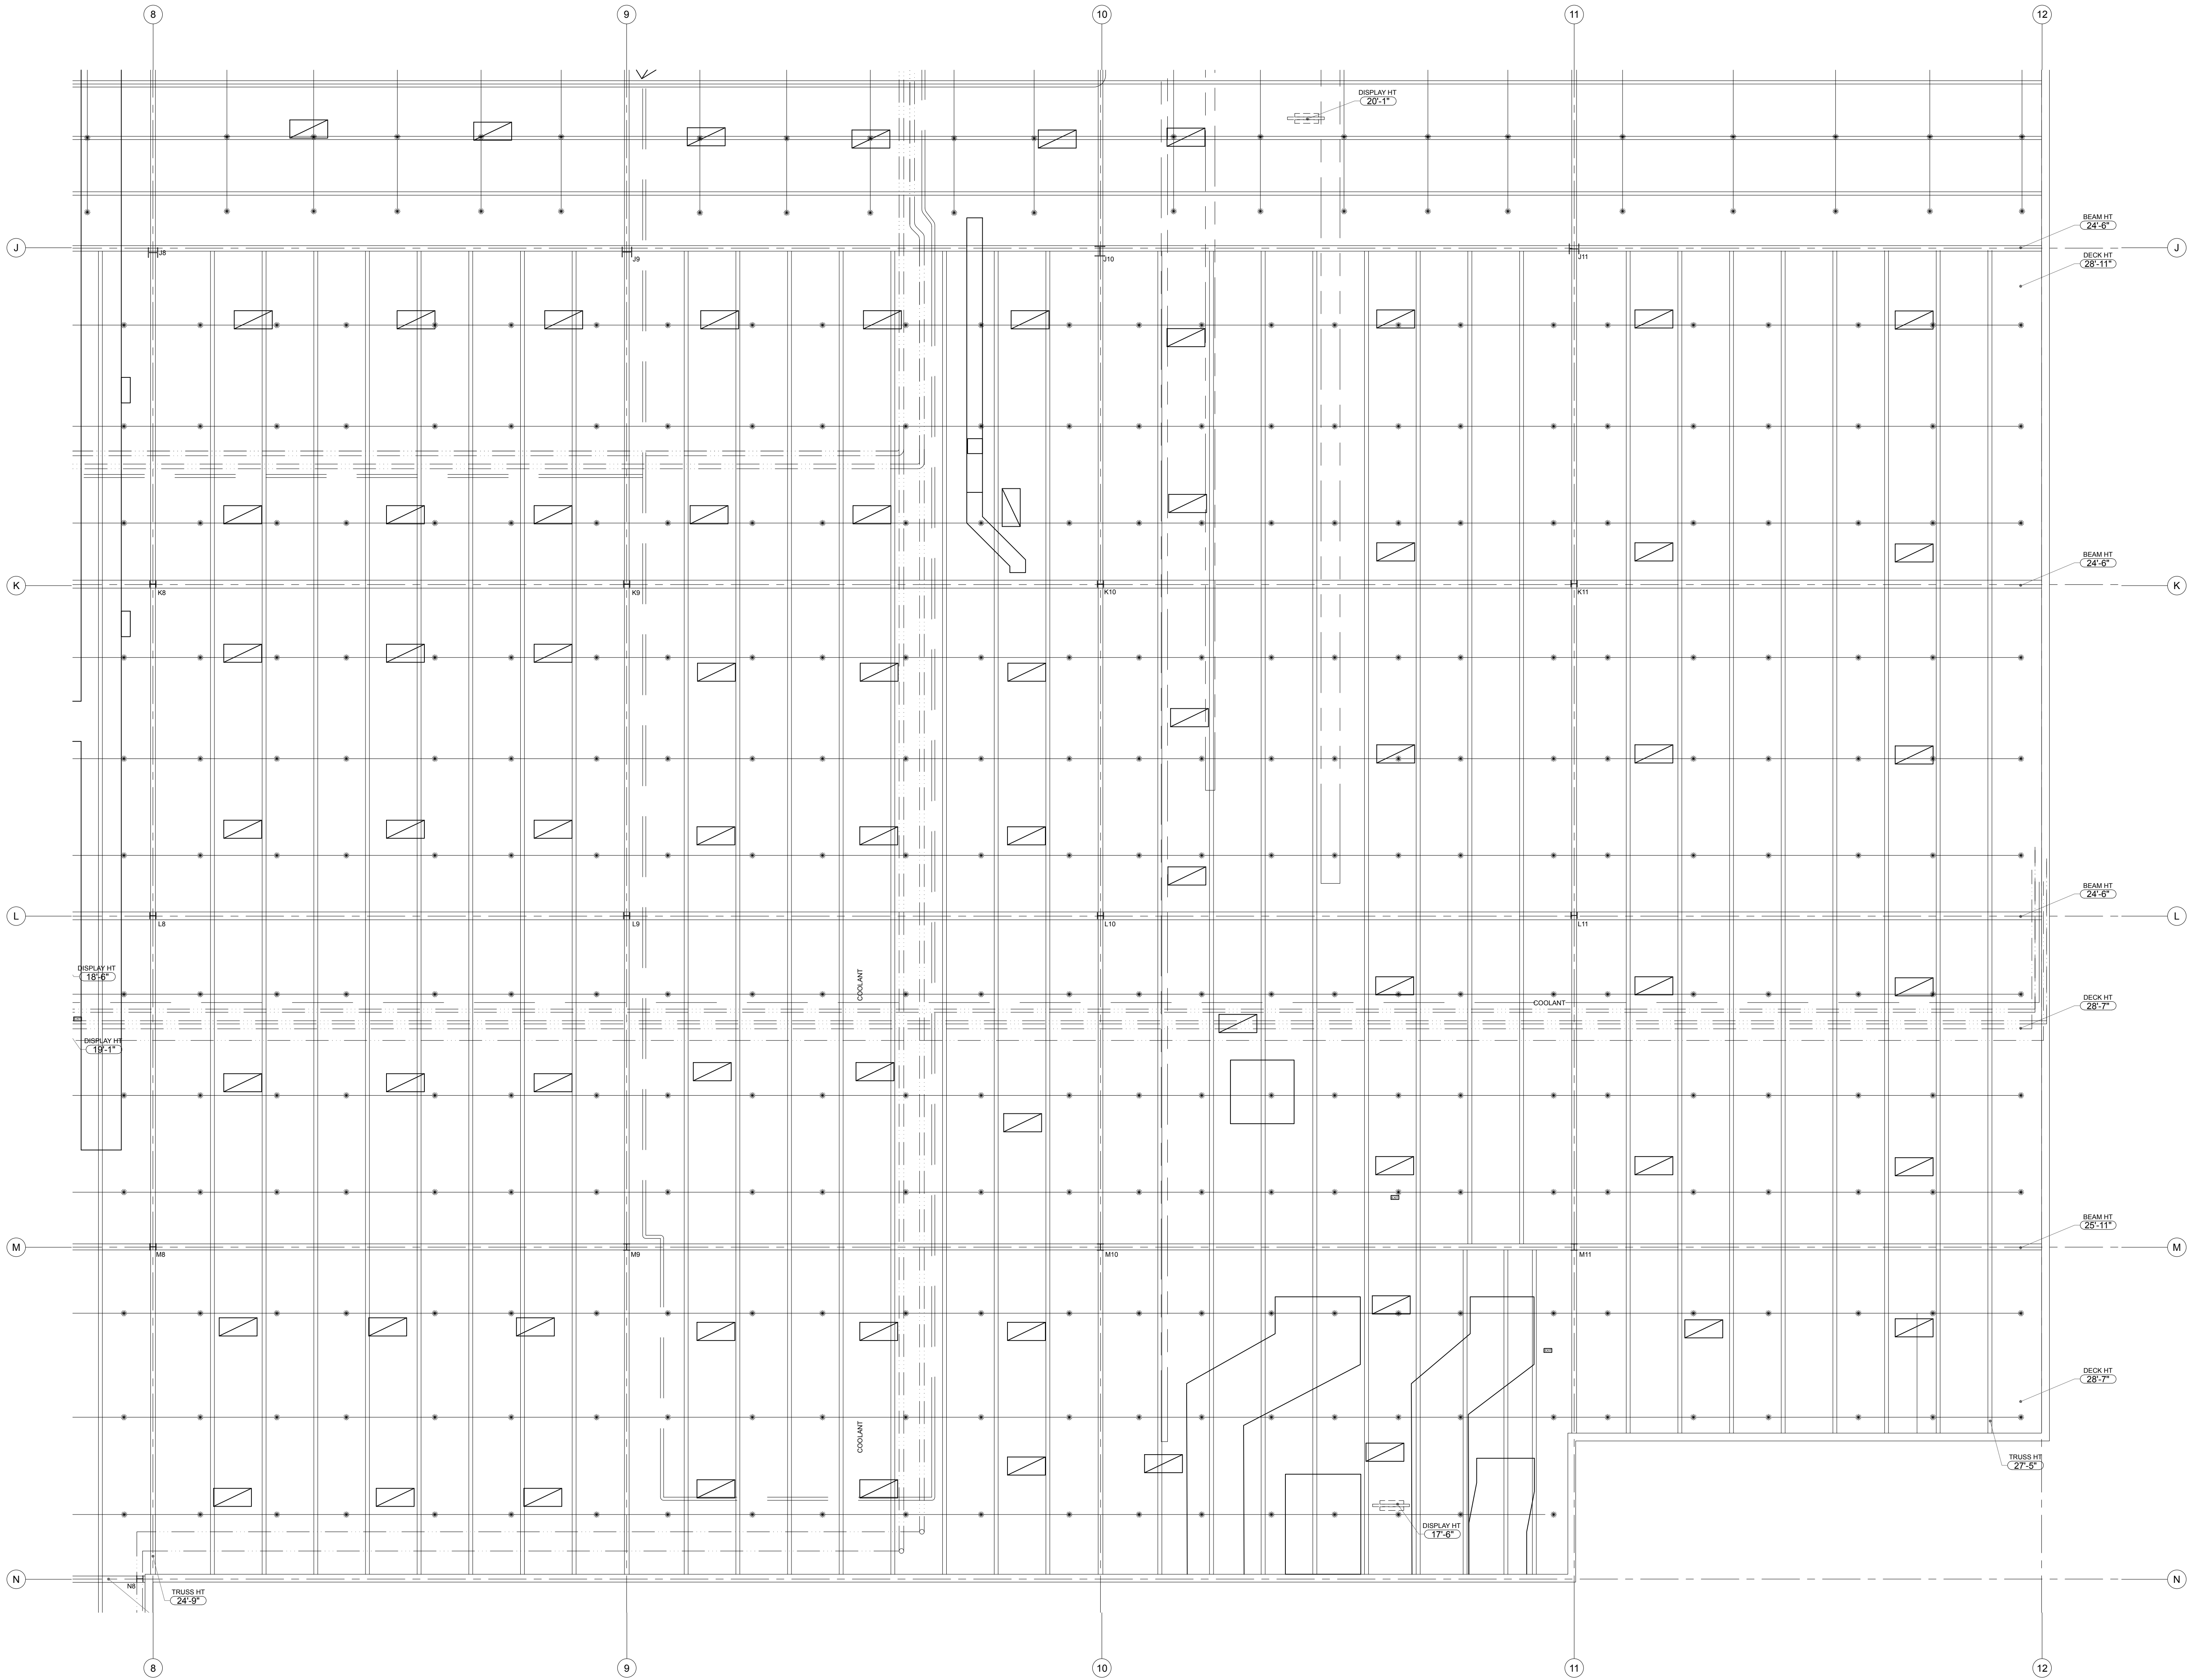

As BUILT

PROFESSIONALS

www.asbuiltprofessionals.com

A DIVISION OF:

AEC

CONSULTANTS INC

844.272.8458

844 AS BUILT

@ 2019 AEC CONSULTANTS INC


ARCHITECTURAL AS BUILT

NIKE MANUFACTURING

ST. CHARLES, MO

01	100% SUBMISSION	SEE COVER SHEET
NO.	ISSUES REVISIONS	DATE
		SHEET TITLE
PARTIAL REFLECTED CEILING PLAN		
HL		PROJECT MANAGER
HL		PROJECT DIRECTOR
012317-1		PROJECT NUMBER
1/8"=1'-0"		SCALE
MM		DRAWN BY
		SHEET NUMBER

AB-6

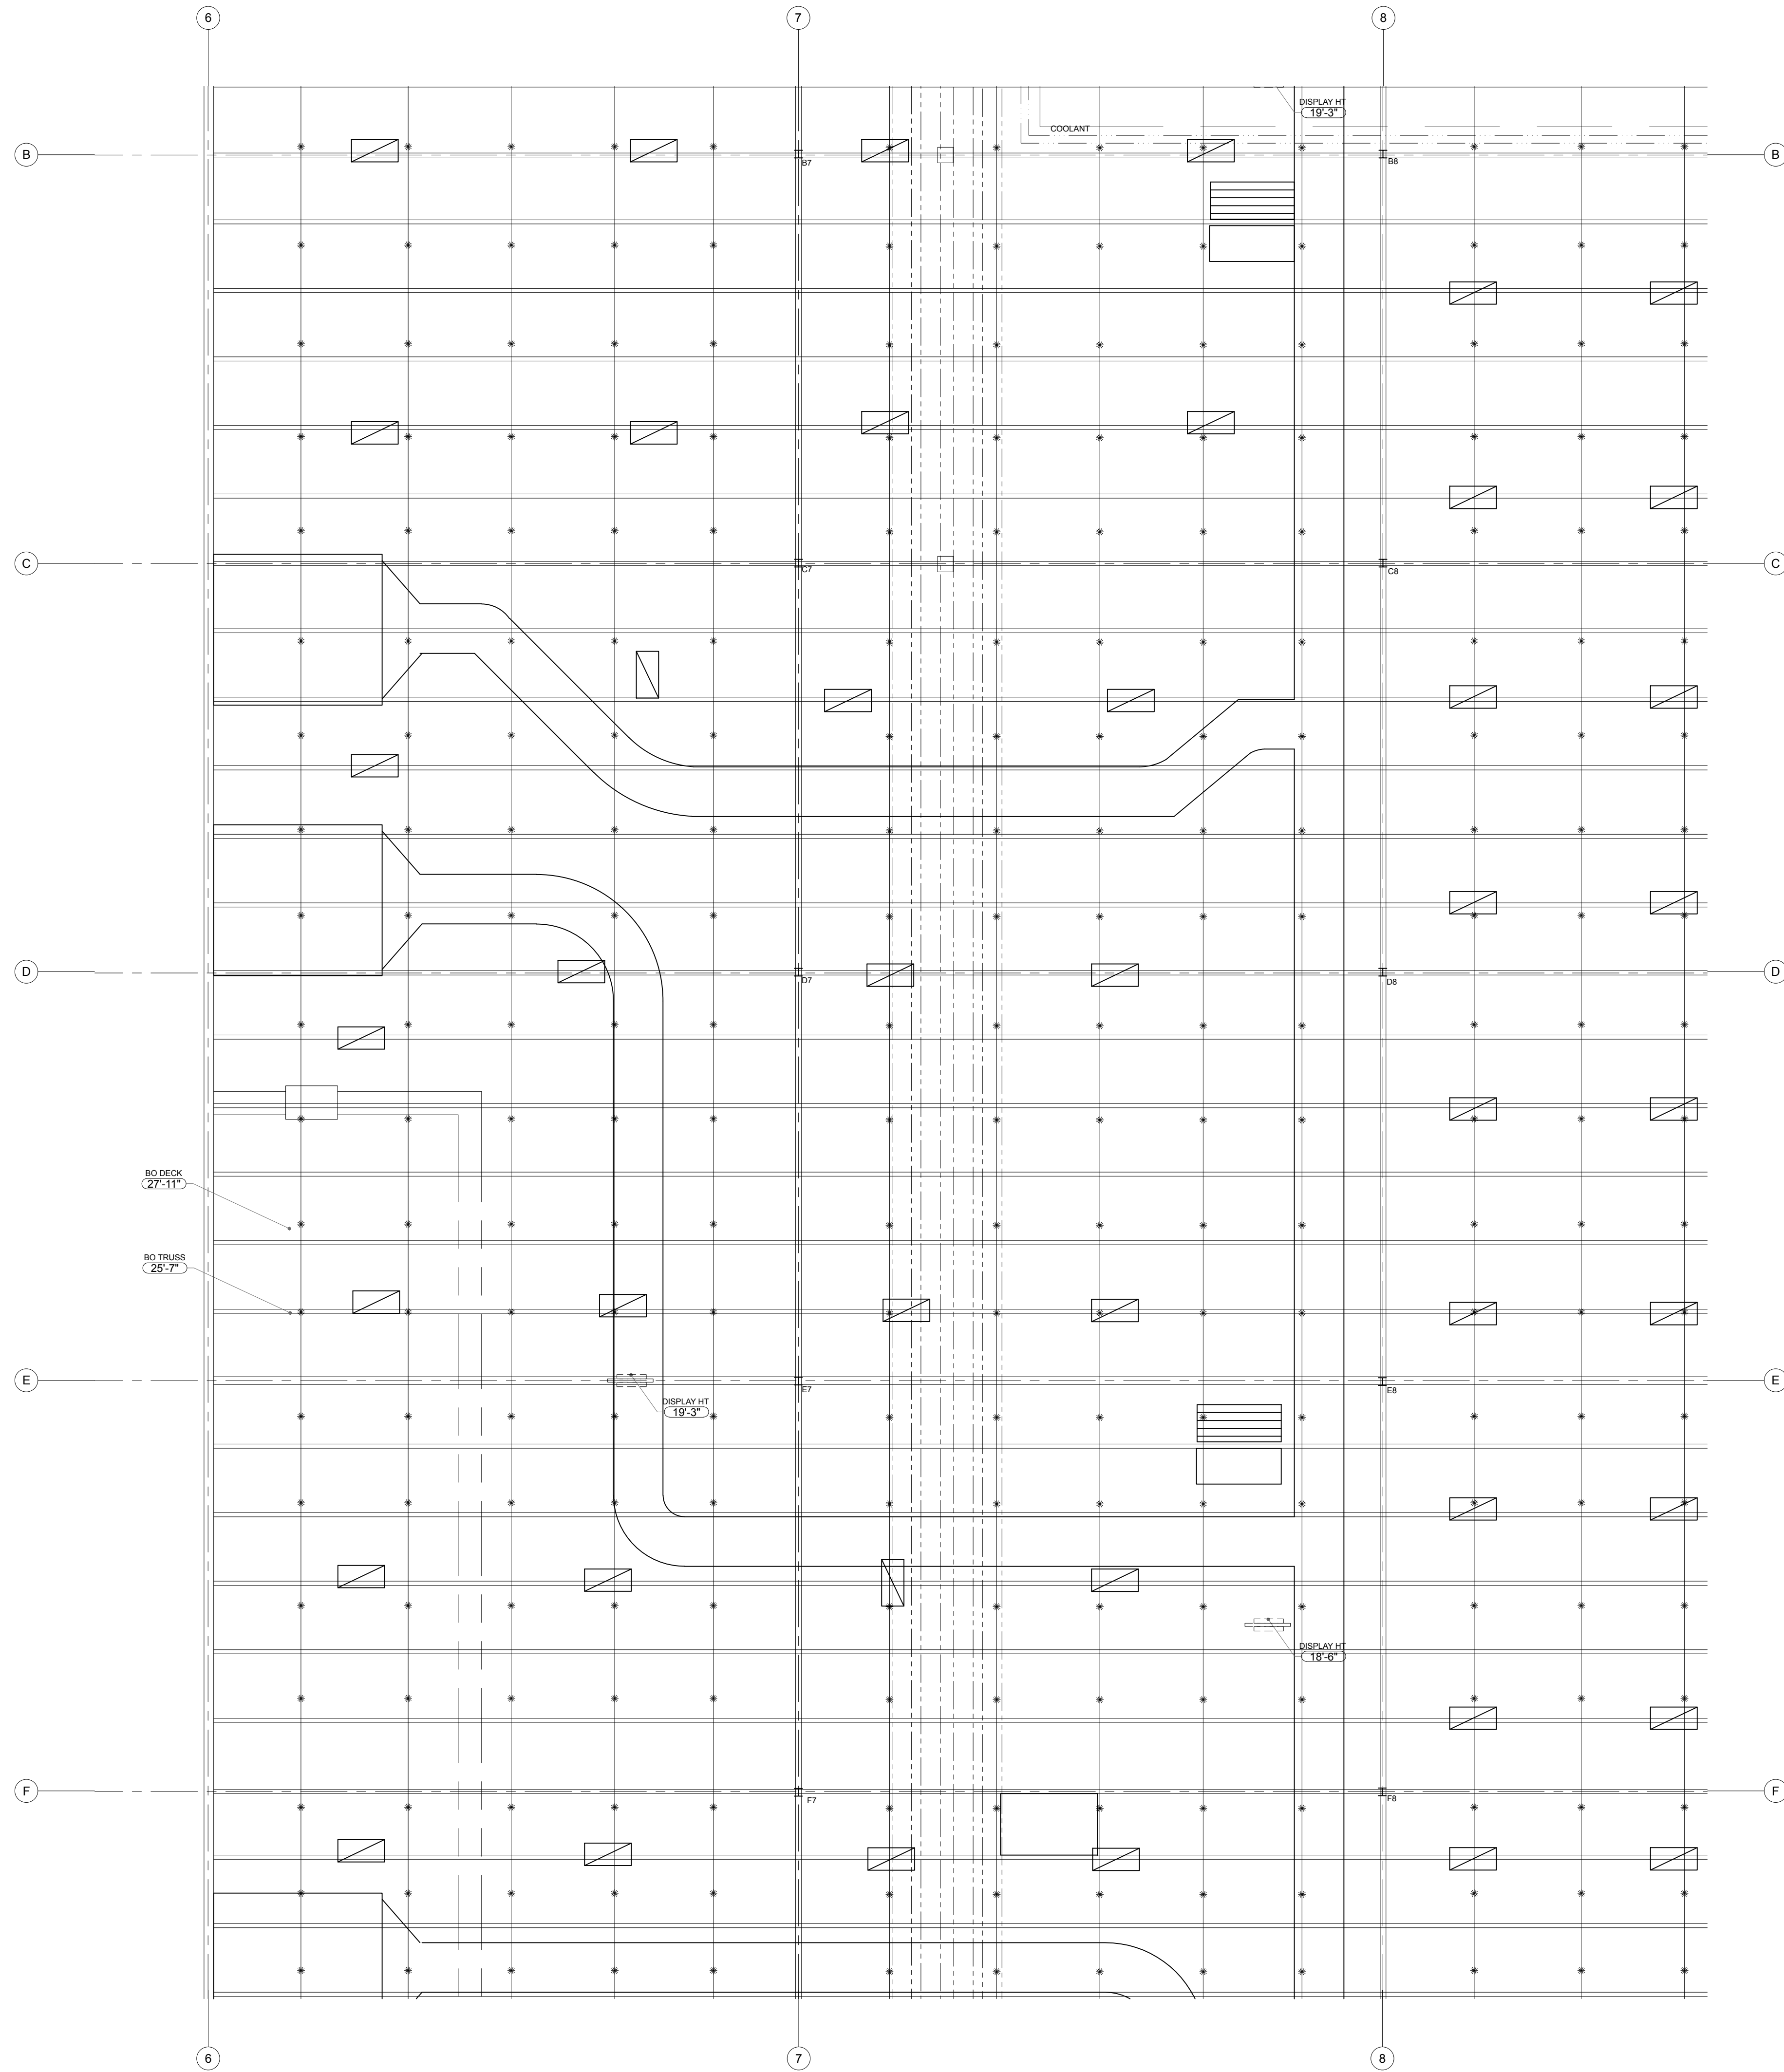

As BUILT

PROFESSIONALS

www.asbuiltprofessionals.com

A DIVISION OF:

AEC

CONSULTANTS INC

844.272.8458

844 AS BUILT

@ 2019 AEC CONSULTANTS INC


ARCHITECTURAL AS BUILT

NIKE MANUFACTURING

ST. CHARLES, MO

01	100% SUBMISSION	SEE COVER SHEET
NO.	ISSUES REVISIONS	DATE
SHEET TITLE		
PARTIAL REFLECTED CEILING PLAN		
HL	PROJECT MANAGER	
HL	PROJECT DIRECTOR	
012317-1	PROJECT NUMBER	
1/8"=1'-0"	SCALE	
MM	DRAWN BY	
SHEET NUMBER		

AB-7

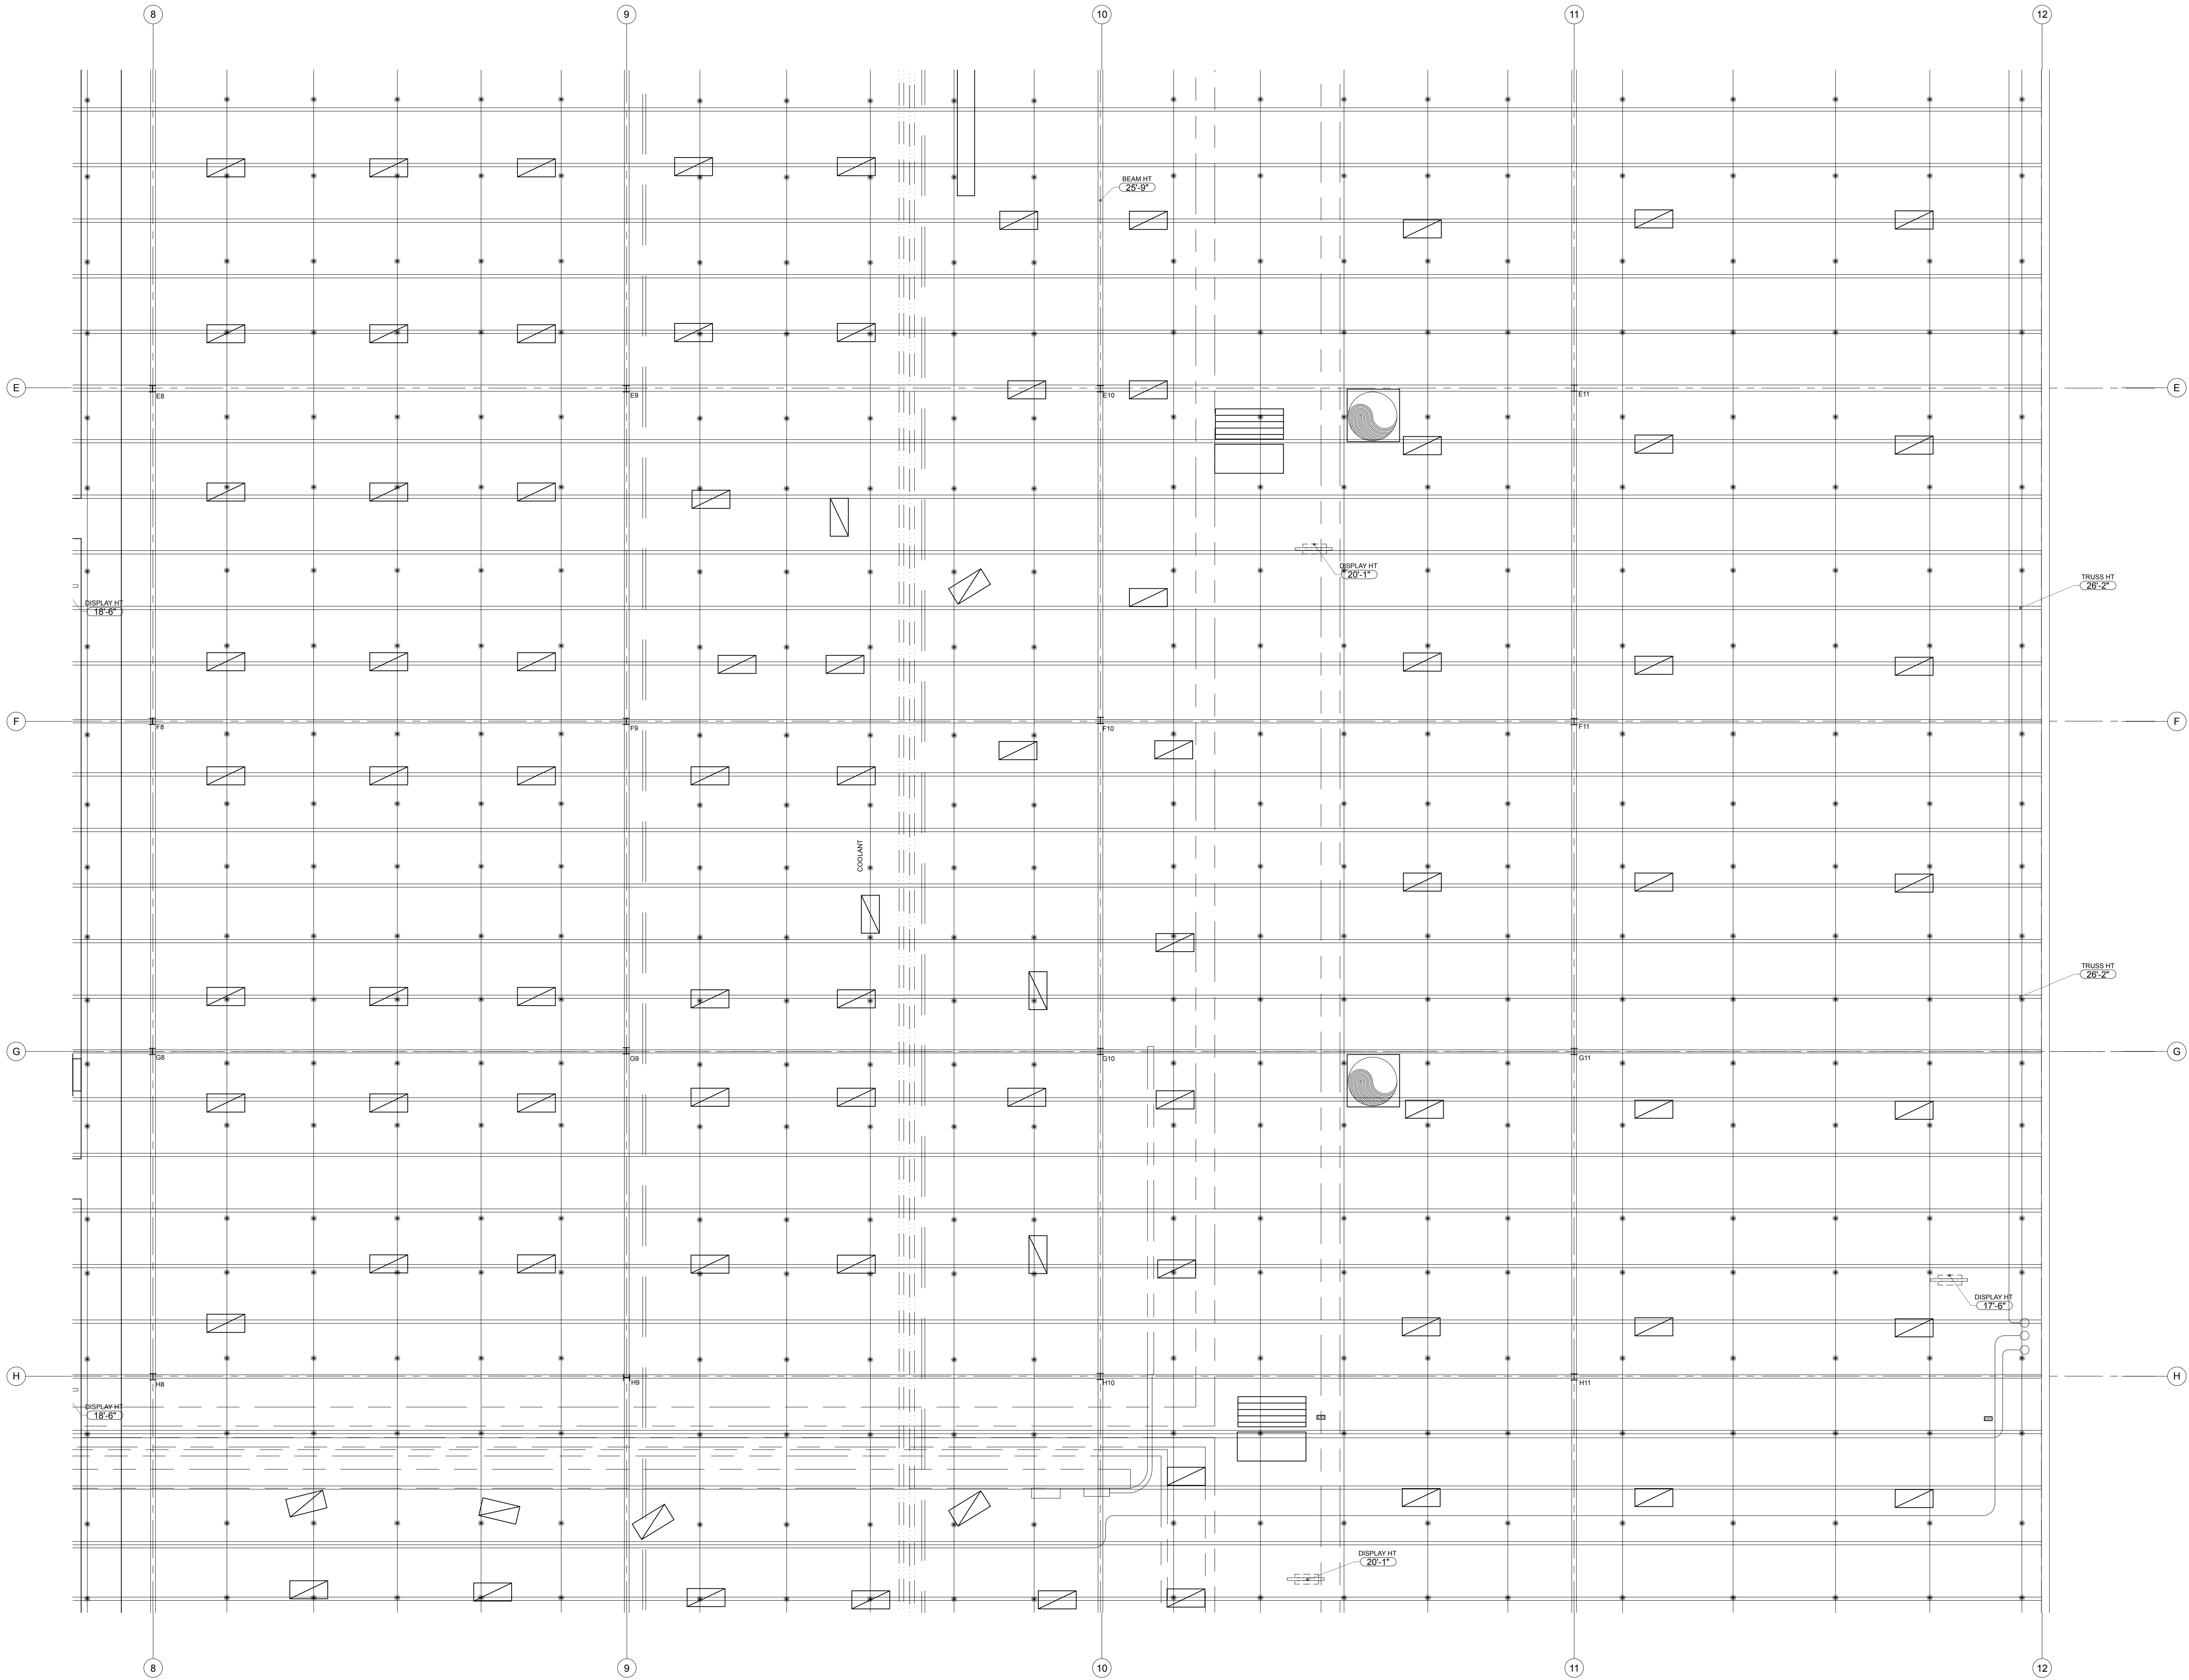

As BUILT

PROFESSIONALS

www.asbuiltprofessionals.com

A DIVISION OF:

AEC

CONSULTANTS INC

844.272.8458

844 AS BUILT

© 2019 AEC CONSULTANTS INC

ARCHITECTURAL AS BUILT

NIKE MANUFACTURING

ST. CHARLES, MO

01	100% SUBMISSION	SEE COVER SHEET
NO.	ISSUES REVISIONS	DATE
		SHEET TITLE
PARTIAL REFLECTED CEILING PLAN		
HL	PROJECT MANAGER	
HL	PROJECT DIRECTOR	
012317-1	PROJECT NUMBER	
1/8"=1'-0"	SCALE	
MM	DRAWN BY	
		SHEET NUMBER


AB-8



PARTIAL REFLECTED CEILING PLAN

HL	PROJECT MANAGER
HL	PROJECT DIRECTOR
012317-1	PROJECT NUMBER
1/8"=1'-0"	SCALE
MM	DRAWN BY
	SHEET NUMBER

AB-9

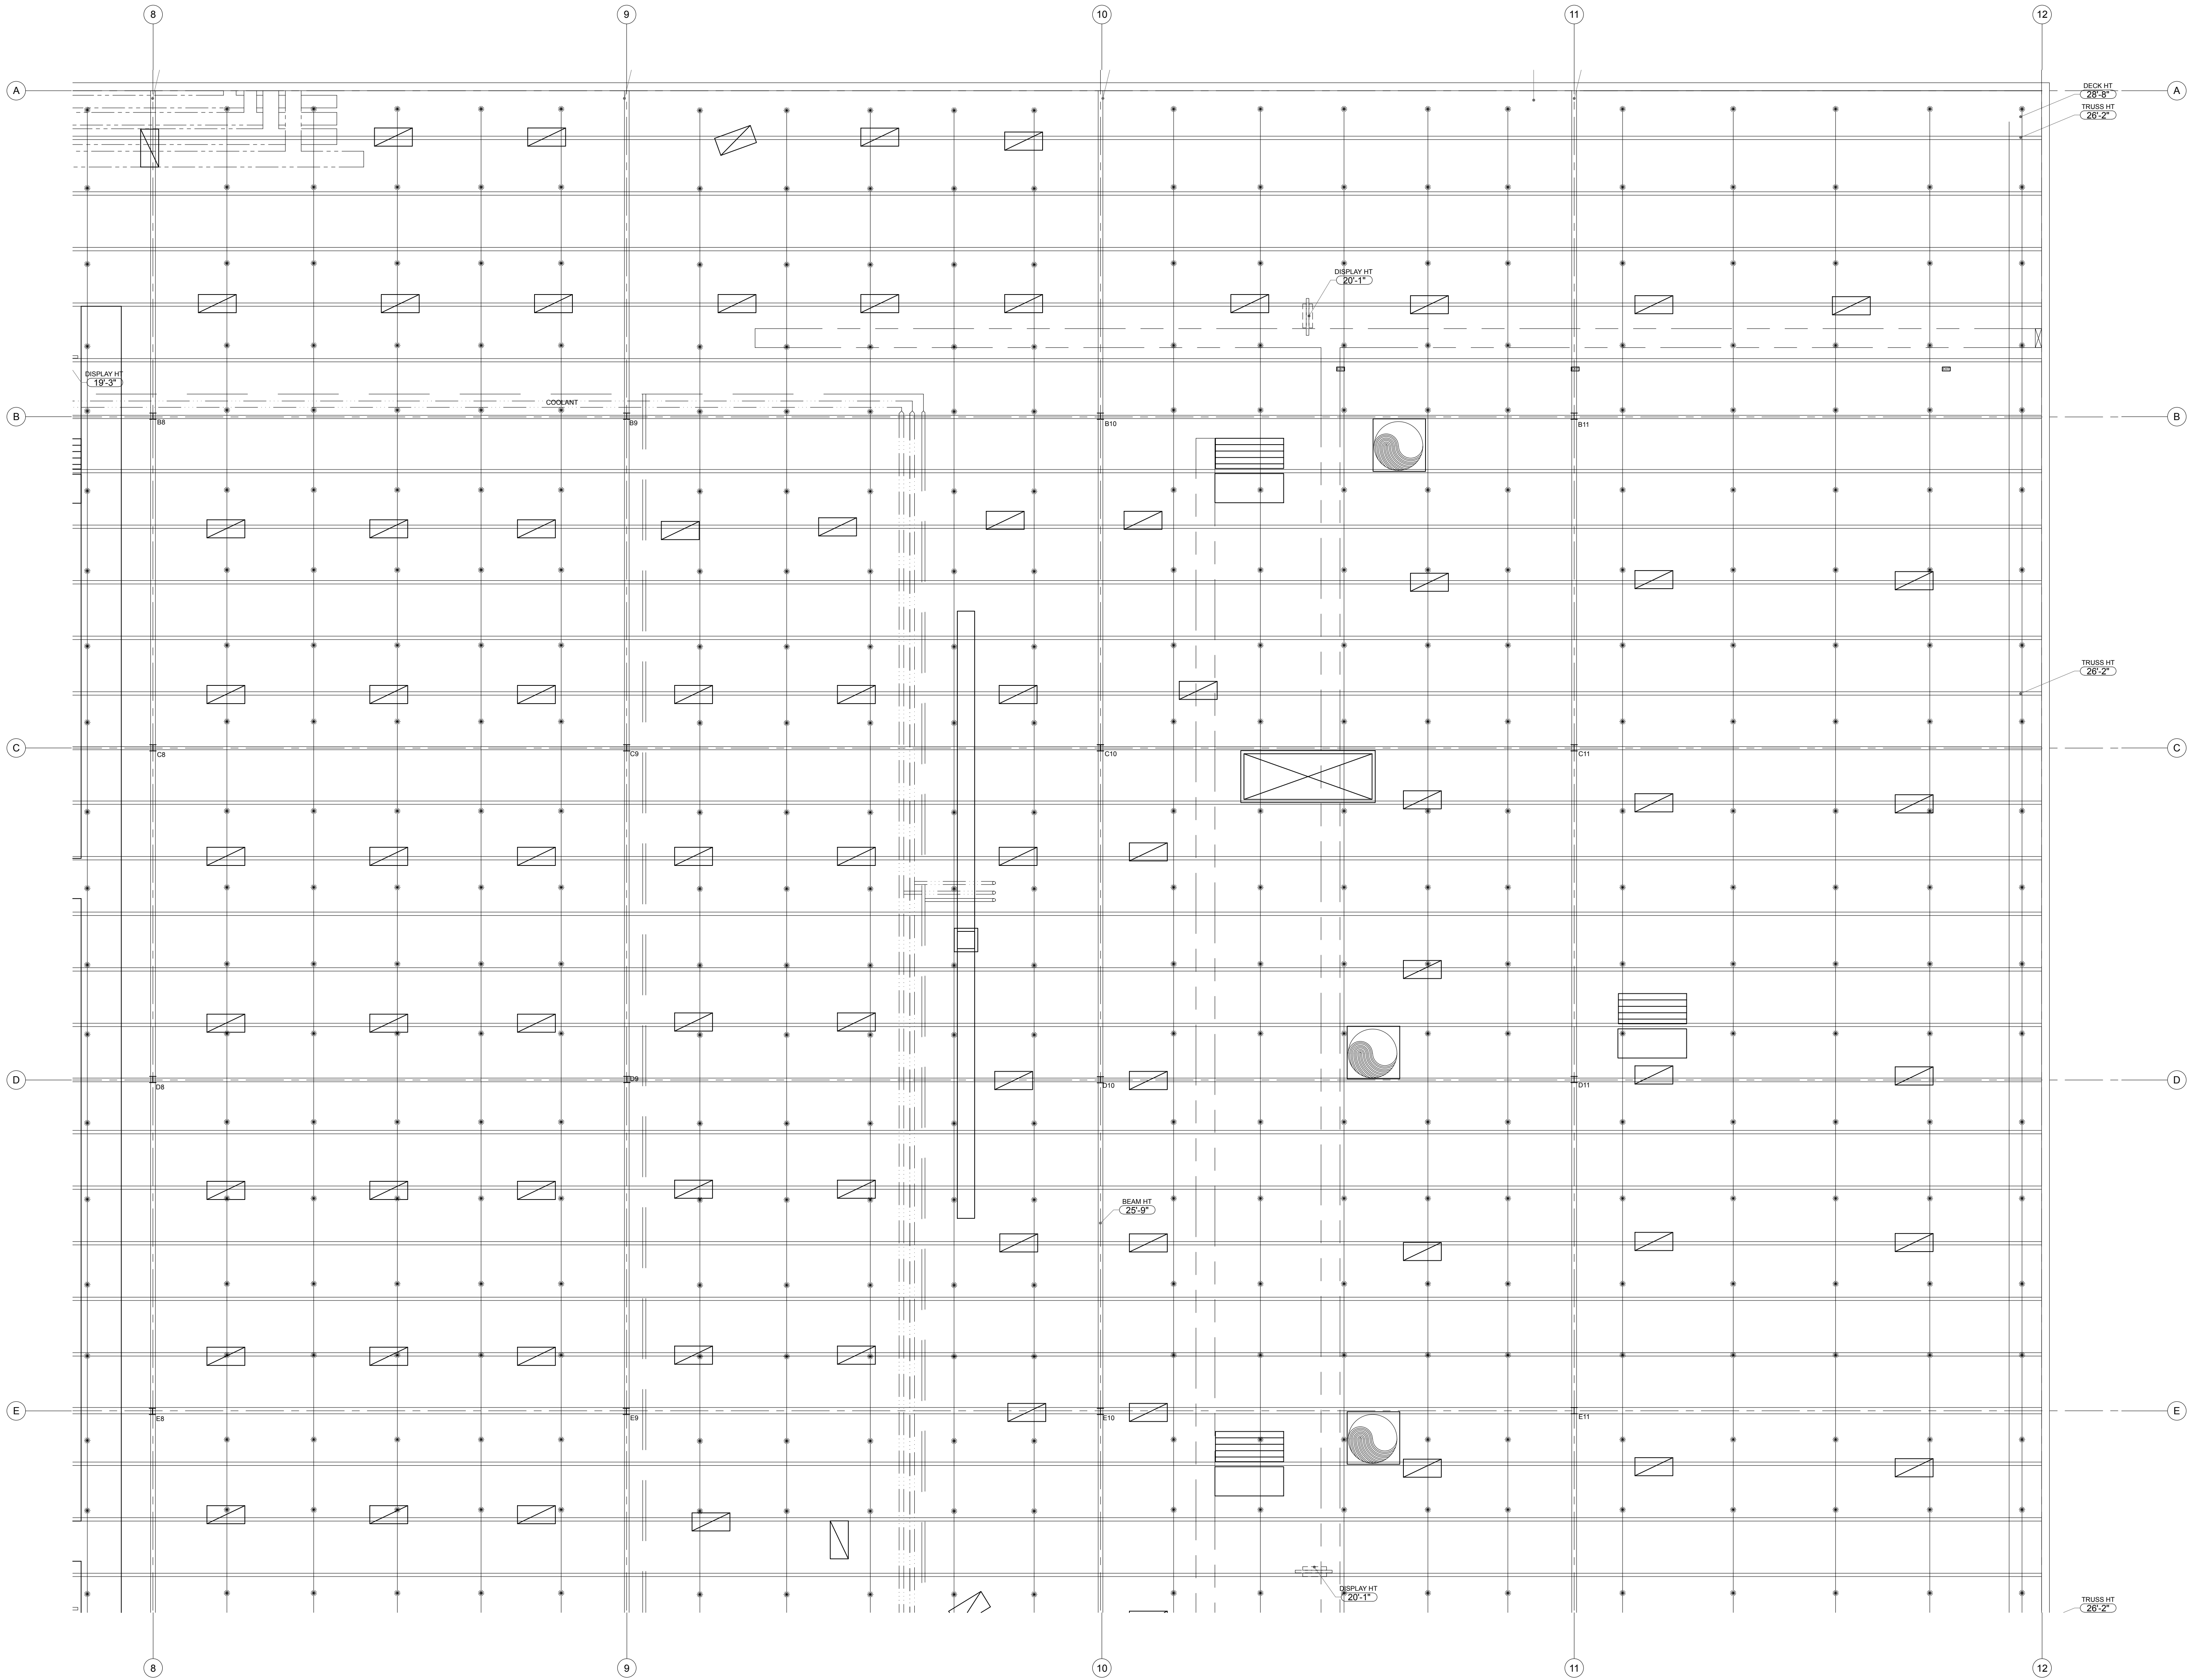

As BUILT

PROFESSIONALS

www.asbuiltprofessionals.com

A DIVISION OF:

AEC

CONSULTANTS INC

844.272.8458

844 AS BUILT

© 2019 AEC CONSULTANTS INC

ARCHITECTURAL AS BUILT

NIKE MANUFACTURING

ST. CHARLES, MO

01	100% SUBMISSION	SEE COVER SHEET
NO.	ISSUES REVISIONS	DATE
		SHEET TITLE
PARTIAL REFLECTED CEILING PLAN		
HL	PROJECT MANAGER	
HL	PROJECT DIRECTOR	
012317-1	PROJECT NUMBER	
1/8"=1'-0"	SCALE	
MM	DRAWN BY	
		SHEET NUMBER

AB-10