

# AS-BUILT DOCUMENTATION

## Worship Center and School MIAMI, FL 33150

### DRAWING INDEX


- C-1 COVER SHEET | DRAWING INDEX
- SL SYMBOLS LEGEND
- AB-1 FIRST FLOOR PLANS
- AB-2 SECOND FLOOR PLANS
- AB-3 FIRST FLOOR REFLECTED CEILING PLANS
- AB-4 SECOND FLOOR REFLECTED CEILING PLANS

**AS BUILT**  
PROFESSIONALS  
www.asbuiltprofessionals.com  
A DIVISION OF:

**AEC**  
CONSULTANTS INC  
844.272.8458  
844 AS BUILT

© 2020 AEC CONSULTANTS INC

**ARCHITECTURAL AS BUILT  
MIAMI, FL 33150**

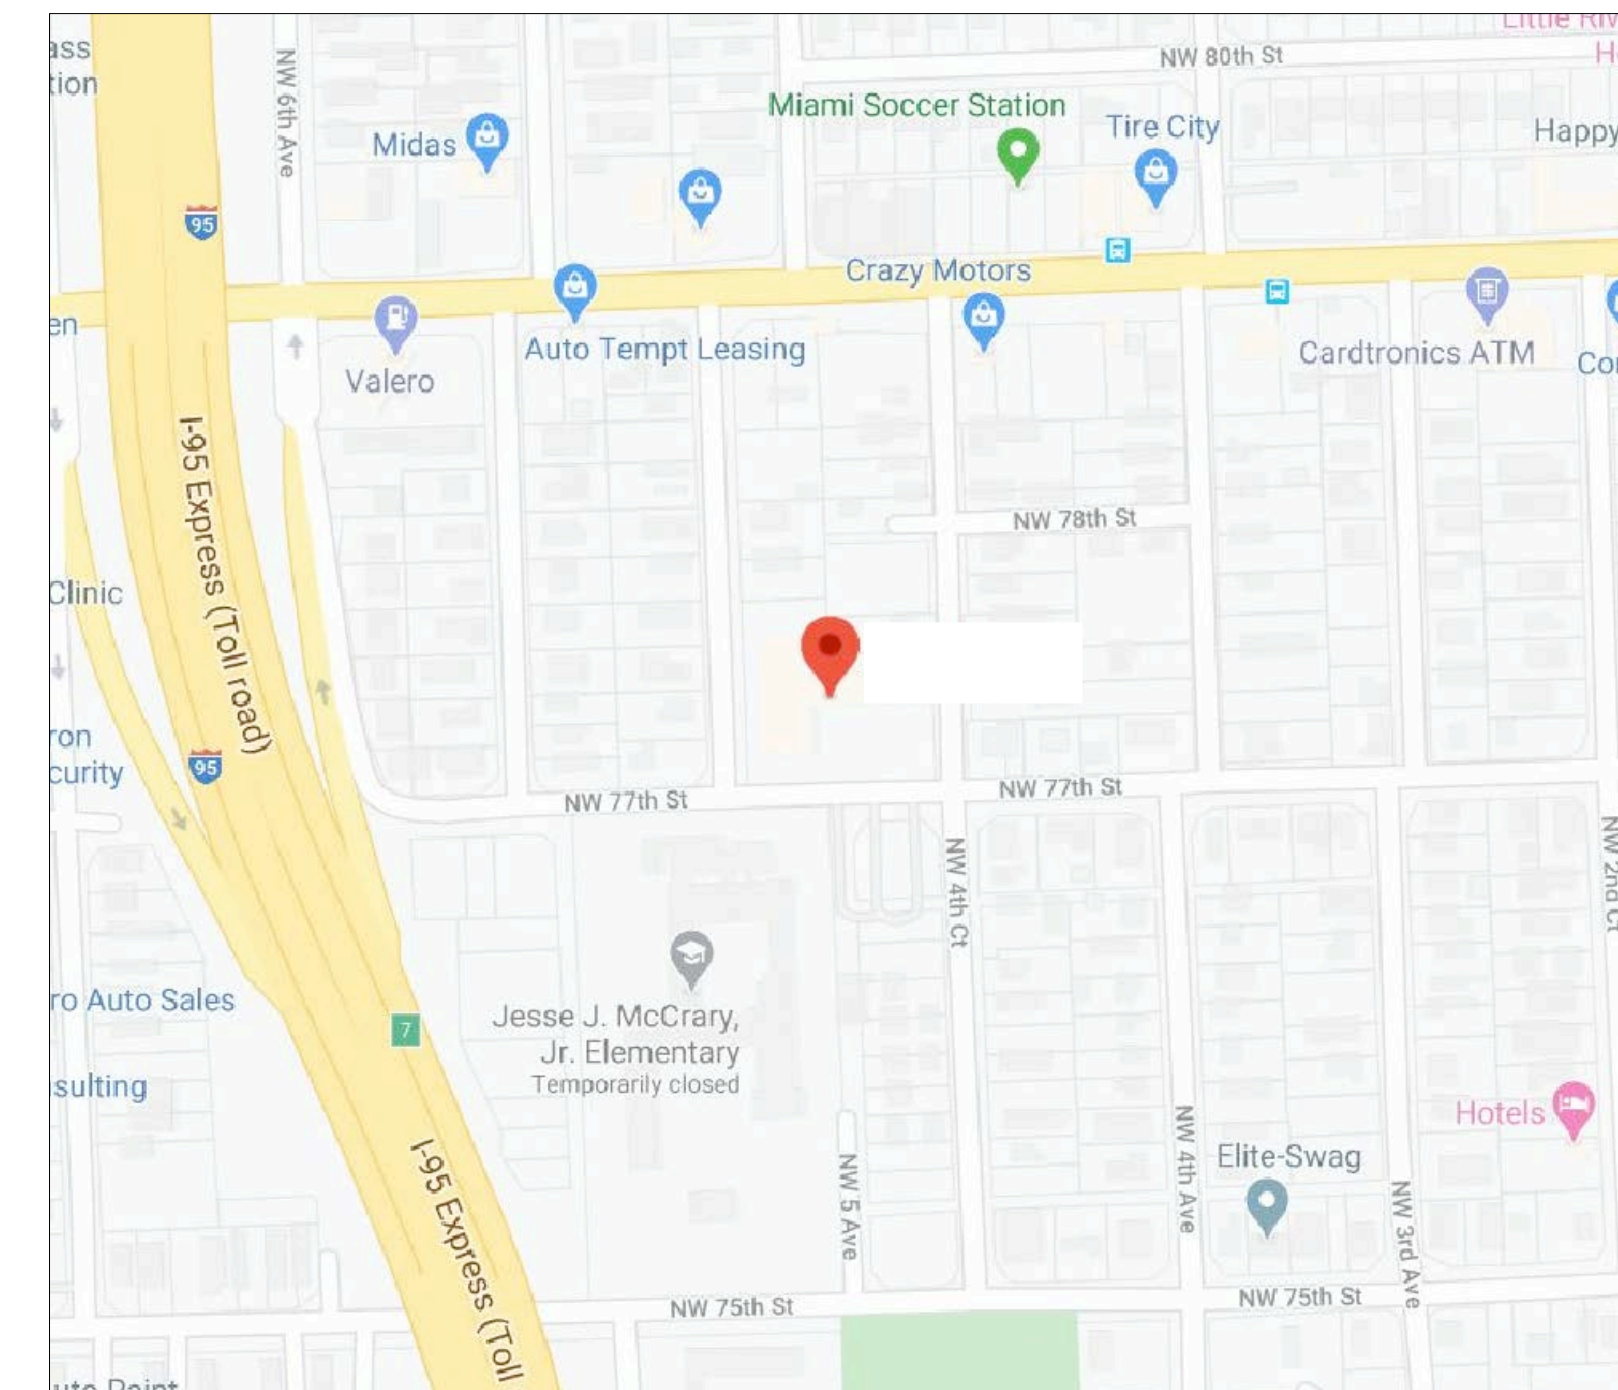

**VICINITY MAP**  
NTS



**100% SUBMITTAL**

DOCUMENTED AREA DATA	
FIRST FLOOR	18,523 SQ. FT. ±
SECOND FLOOR	10,381 SQ. FT. ±
<b>GRAND TOTAL</b>	<b>28,904 SQ. FT. ±</b>

01	100% SUBMISSION	SEE COVER SHEET
NO.	ISSUES   REVISIONS	DATE

<b>COVER</b>	
HL	PROJECT MANAGER
HL	PROJECT DIRECTOR
012317-1	PROJECT NUMBER
	SCALE
CL	DRAWN BY
	SHEET NUMBER

**C1**

# SYMBOLS LEGEND

## RCP

- |  |                                              |  |                                                                                                                                                                                   |
|--|----------------------------------------------|--|-----------------------------------------------------------------------------------------------------------------------------------------------------------------------------------|
|  | EXHAUST VENT                                 |  | TRACK LIGHT OR VANITY LIGHT                                                                                                                                                       |
|  | CEILING MOUNTED LIGHT FIXTURE                |  | WALL-MOUNTED LIGHT FIXTURE                                                                                                                                                        |
|  | CEILING MOUNTED DIRECTIONAL LIGHT            |  | EMERGENCY EXIT SIGN                                                                                                                                                               |
|  | RECESSED CAN LIGHT                           |  | EMERGENCY EXIT LIGHT                                                                                                                                                              |
|  | EYEBALL OR SMALL CAN LIGHT                   |  | EMERGENCY EXIT LIGHT W/ SIGN                                                                                                                                                      |
|  | PENDANT LIGHT                                |  | LIGHTED STAIR SIGN                                                                                                                                                                |
|  | INDIVIDUAL FLUOR. LAY-IN FIXTURE 4 BULB      |  | FLOOD LIGHT                                                                                                                                                                       |
|  | INDIVIDUAL FLUOR. HANGING FIXTURE 2 BULB     |  | PHOTO CELL                                                                                                                                                                        |
|  | INDIVIDUAL FLUOR. FLUSH MOUNT FIXTURE 4 BULB |  | CEILING FAN                                                                                                                                                                       |
|  | CAMERA                                       |  | CEILING FAN W/ LIGHT KIT                                                                                                                                                          |
|  | MOTION DET.                                  |  | 7-2-6 CEILING HEIGHT AND TRIM 7'-2" ABOVE FLOOR BELOW WITH 6" CROWN MOULDING. NOTE: ALL CEILINGS NOT LABELED ARE PLASTER. CEILINGS SHOWN WITH A GRID ARE LAY IN ACOUSTICAL TILE.. |
|  | SUPPLY VENT                                  |  | JUNCTION BOX                                                                                                                                                                      |
|  | SUPPLY VENT                                  |  |                                                                                                                                                                                   |
|  | RETURN VENT                                  |  |                                                                                                                                                                                   |
|  | RETURN VENT                                  |  |                                                                                                                                                                                   |
|  | SPEAKER                                      |  |                                                                                                                                                                                   |

## ELECTRIC

- |  |                                      |
|--|--------------------------------------|
|  | DATA OUTLET                          |
|  | TELEPHONE JACK                       |
|  | ELECTRIC SWITCH                      |
|  | CABLE TELEVISION OUTLET              |
|  | DUPLEX RECEPTACLE OUTLET             |
|  | SPECIAL PURPOSE CONNECTION OR OUTLET |
|  | QUADRUPEX RECEPTACLE OUTLET          |
|  | FLOOR DUPLEX RECEPTACLE OUTLET       |
|  | ELECTRIC PANEL                       |
|  | ELECTRIC METER                       |
|  | BUTTON SWITCH                        |
|  | DISCONNECT SWITCH                    |
|  | GROUND/FLOOR LIGHT                   |
|  | KEY PAD                              |

## FIRE PROTECTION


- |  |                              |
|--|------------------------------|
|  | FIRE EXTINGUISHER            |
|  | FIRE PULL                    |
|  | FIRE ALARM (HORN/SRTO)       |
|  | SMOKE DETECTOR               |
|  | SMOKE ALARM SPEAKER          |
|  | SPRINKLER HEAD CEILING MOUNT |
|  | SPRINKLER HEAD WALL MOUNT    |

## MEP


- |  |                      |
|--|----------------------|
|  | THERMOSTAT           |
|  | FLOOR DRAIN          |
|  | VALVE                |
|  | HOSE BIB             |
|  | WATER SUPPLY         |
|  | SUSPENDED GAS HEATER |

## MISC


- |  |                |
|--|----------------|
|  | BOLLARD        |
|  | SPOT ELEVATION |

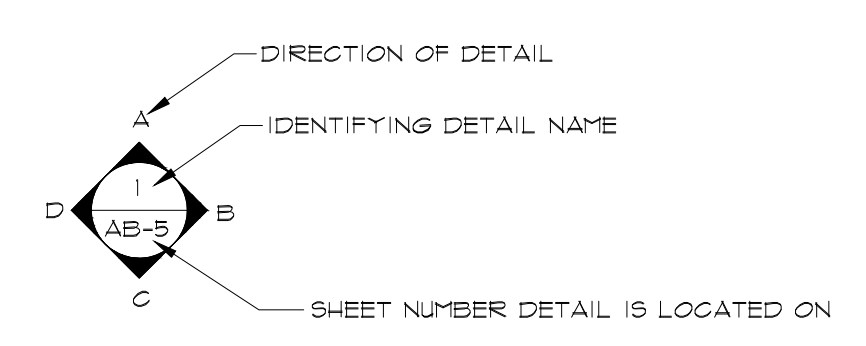

**INTERIOR ELEVATIONS**

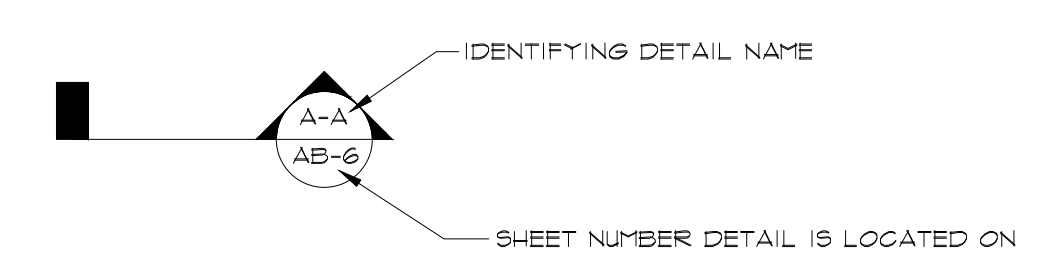

**BUILDING SECTION**

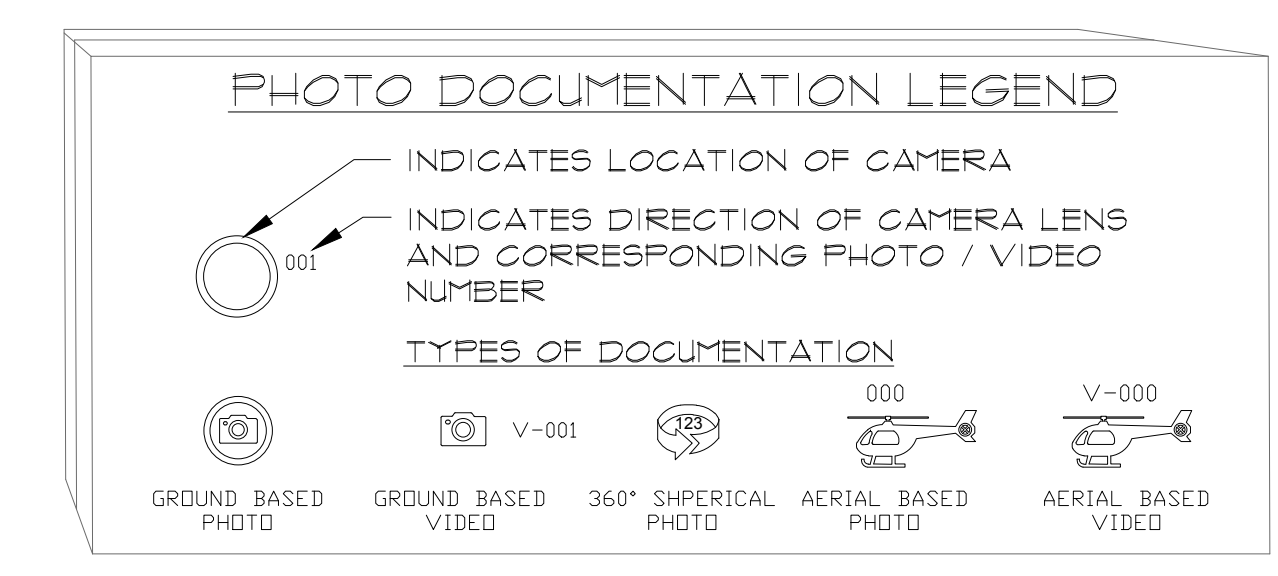

- TYPES OF DOCUMENTATION
- |  |                    |  |                    |  |                      |  |                    |  |                    |
|--|--------------------|--|--------------------|--|----------------------|--|--------------------|--|--------------------|
|  | GROUND BASED PHOTO |  | GROUND BASED VIDEO |  | 360° SPHERICAL PHOTO |  | AERIAL BASED PHOTO |  | AERIAL BASED VIDEO |
|--|--------------------|--|--------------------|--|----------------------|--|--------------------|--|--------------------|

**ARCHITECTURAL AS BUILT**

**MIAMI, FL 33150**

01	100% SUBMISSION	SEE COVER SHEET
NO.	ISSUES   REVISIONS	DATE


SHEET TITLE

**SYMBOL LEGEND**

HL	PROJECT MANAGER
HL	PROJECT DIRECTOR
012317-1	PROJECT NUMBER
	SCALE
CL	DRAWN BY
	SHEET NUMBER

**SL**

**ARCHITECTURAL AS BUILT**  
**MIAMI, FL 33150**

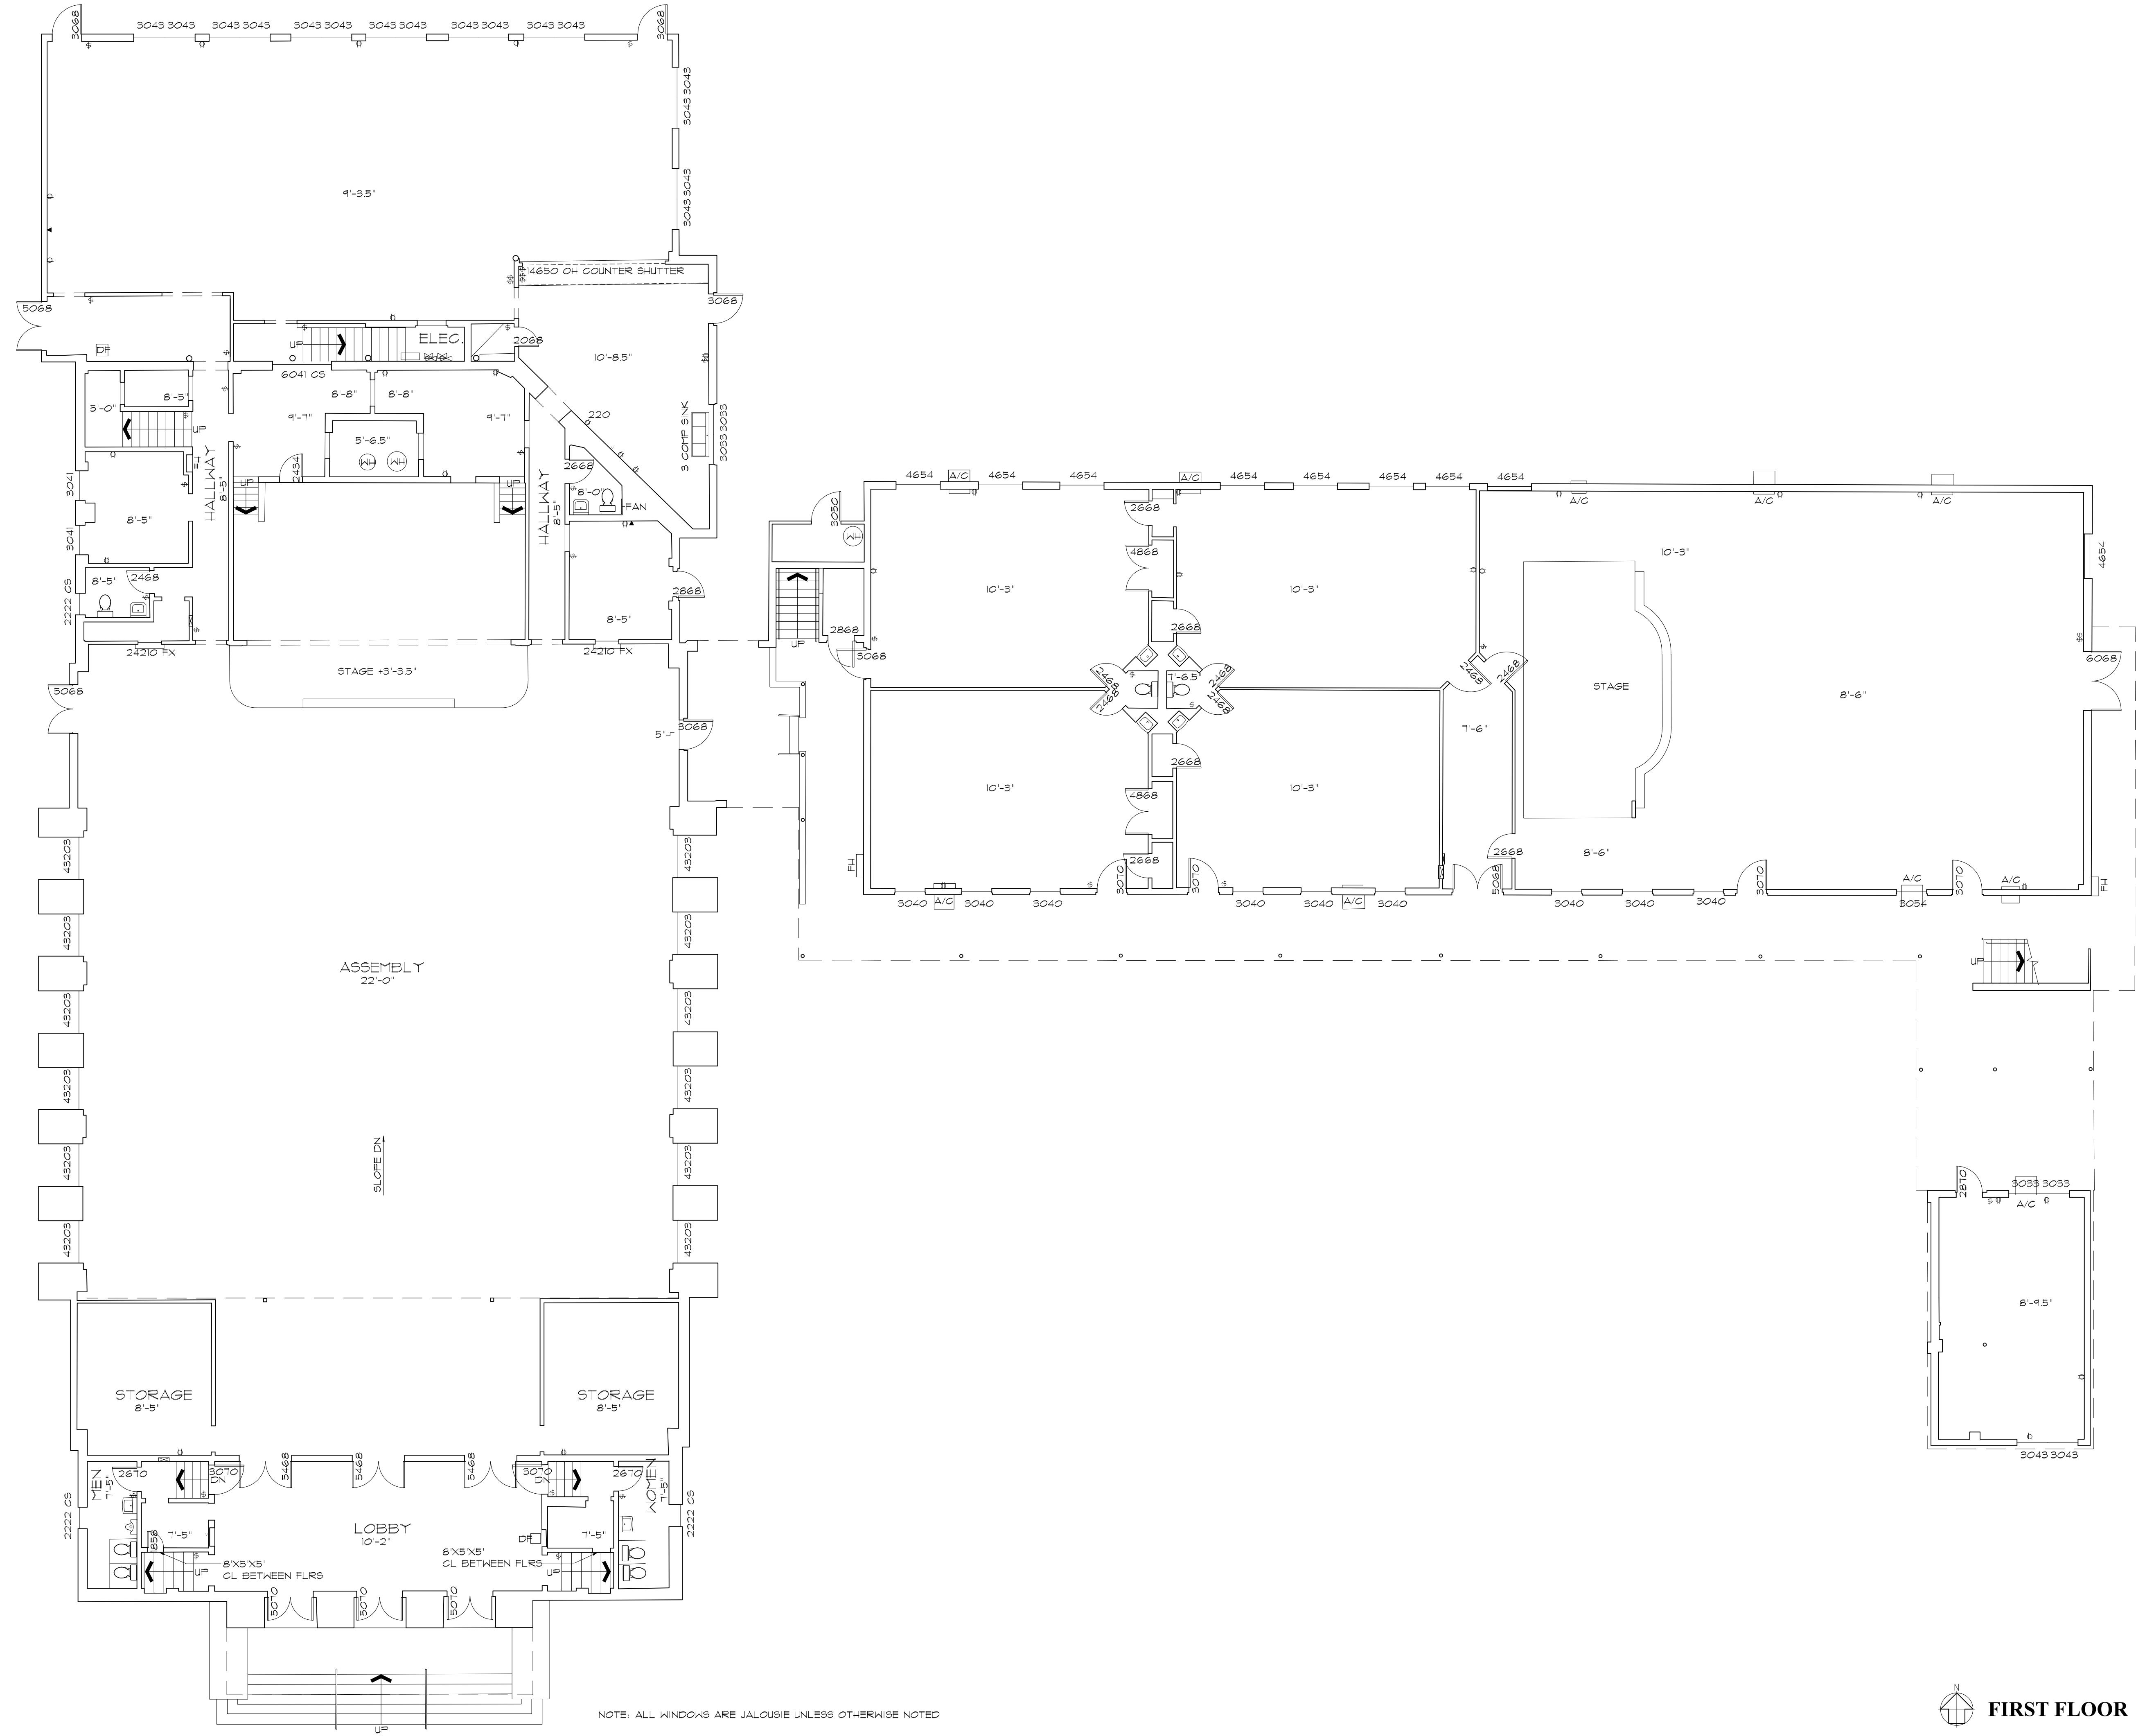


01	100% SUBMISSION	SEE COVER SHEET
NO.	ISSUES   REVISIONS	DATE

SHEET TITLE  
**FIRST FLOOR PLAN**

HL	PROJECT MANAGER
HL	PROJECT DIRECTOR
012317-1	PROJECT NUMBER
<b>1/8"=1'-0"</b>	SCALE
CL	DRAWN BY
	SHEET NUMBER


**ARCHITECTURAL AS BUILT**  
**MIAMI, FL 33150**

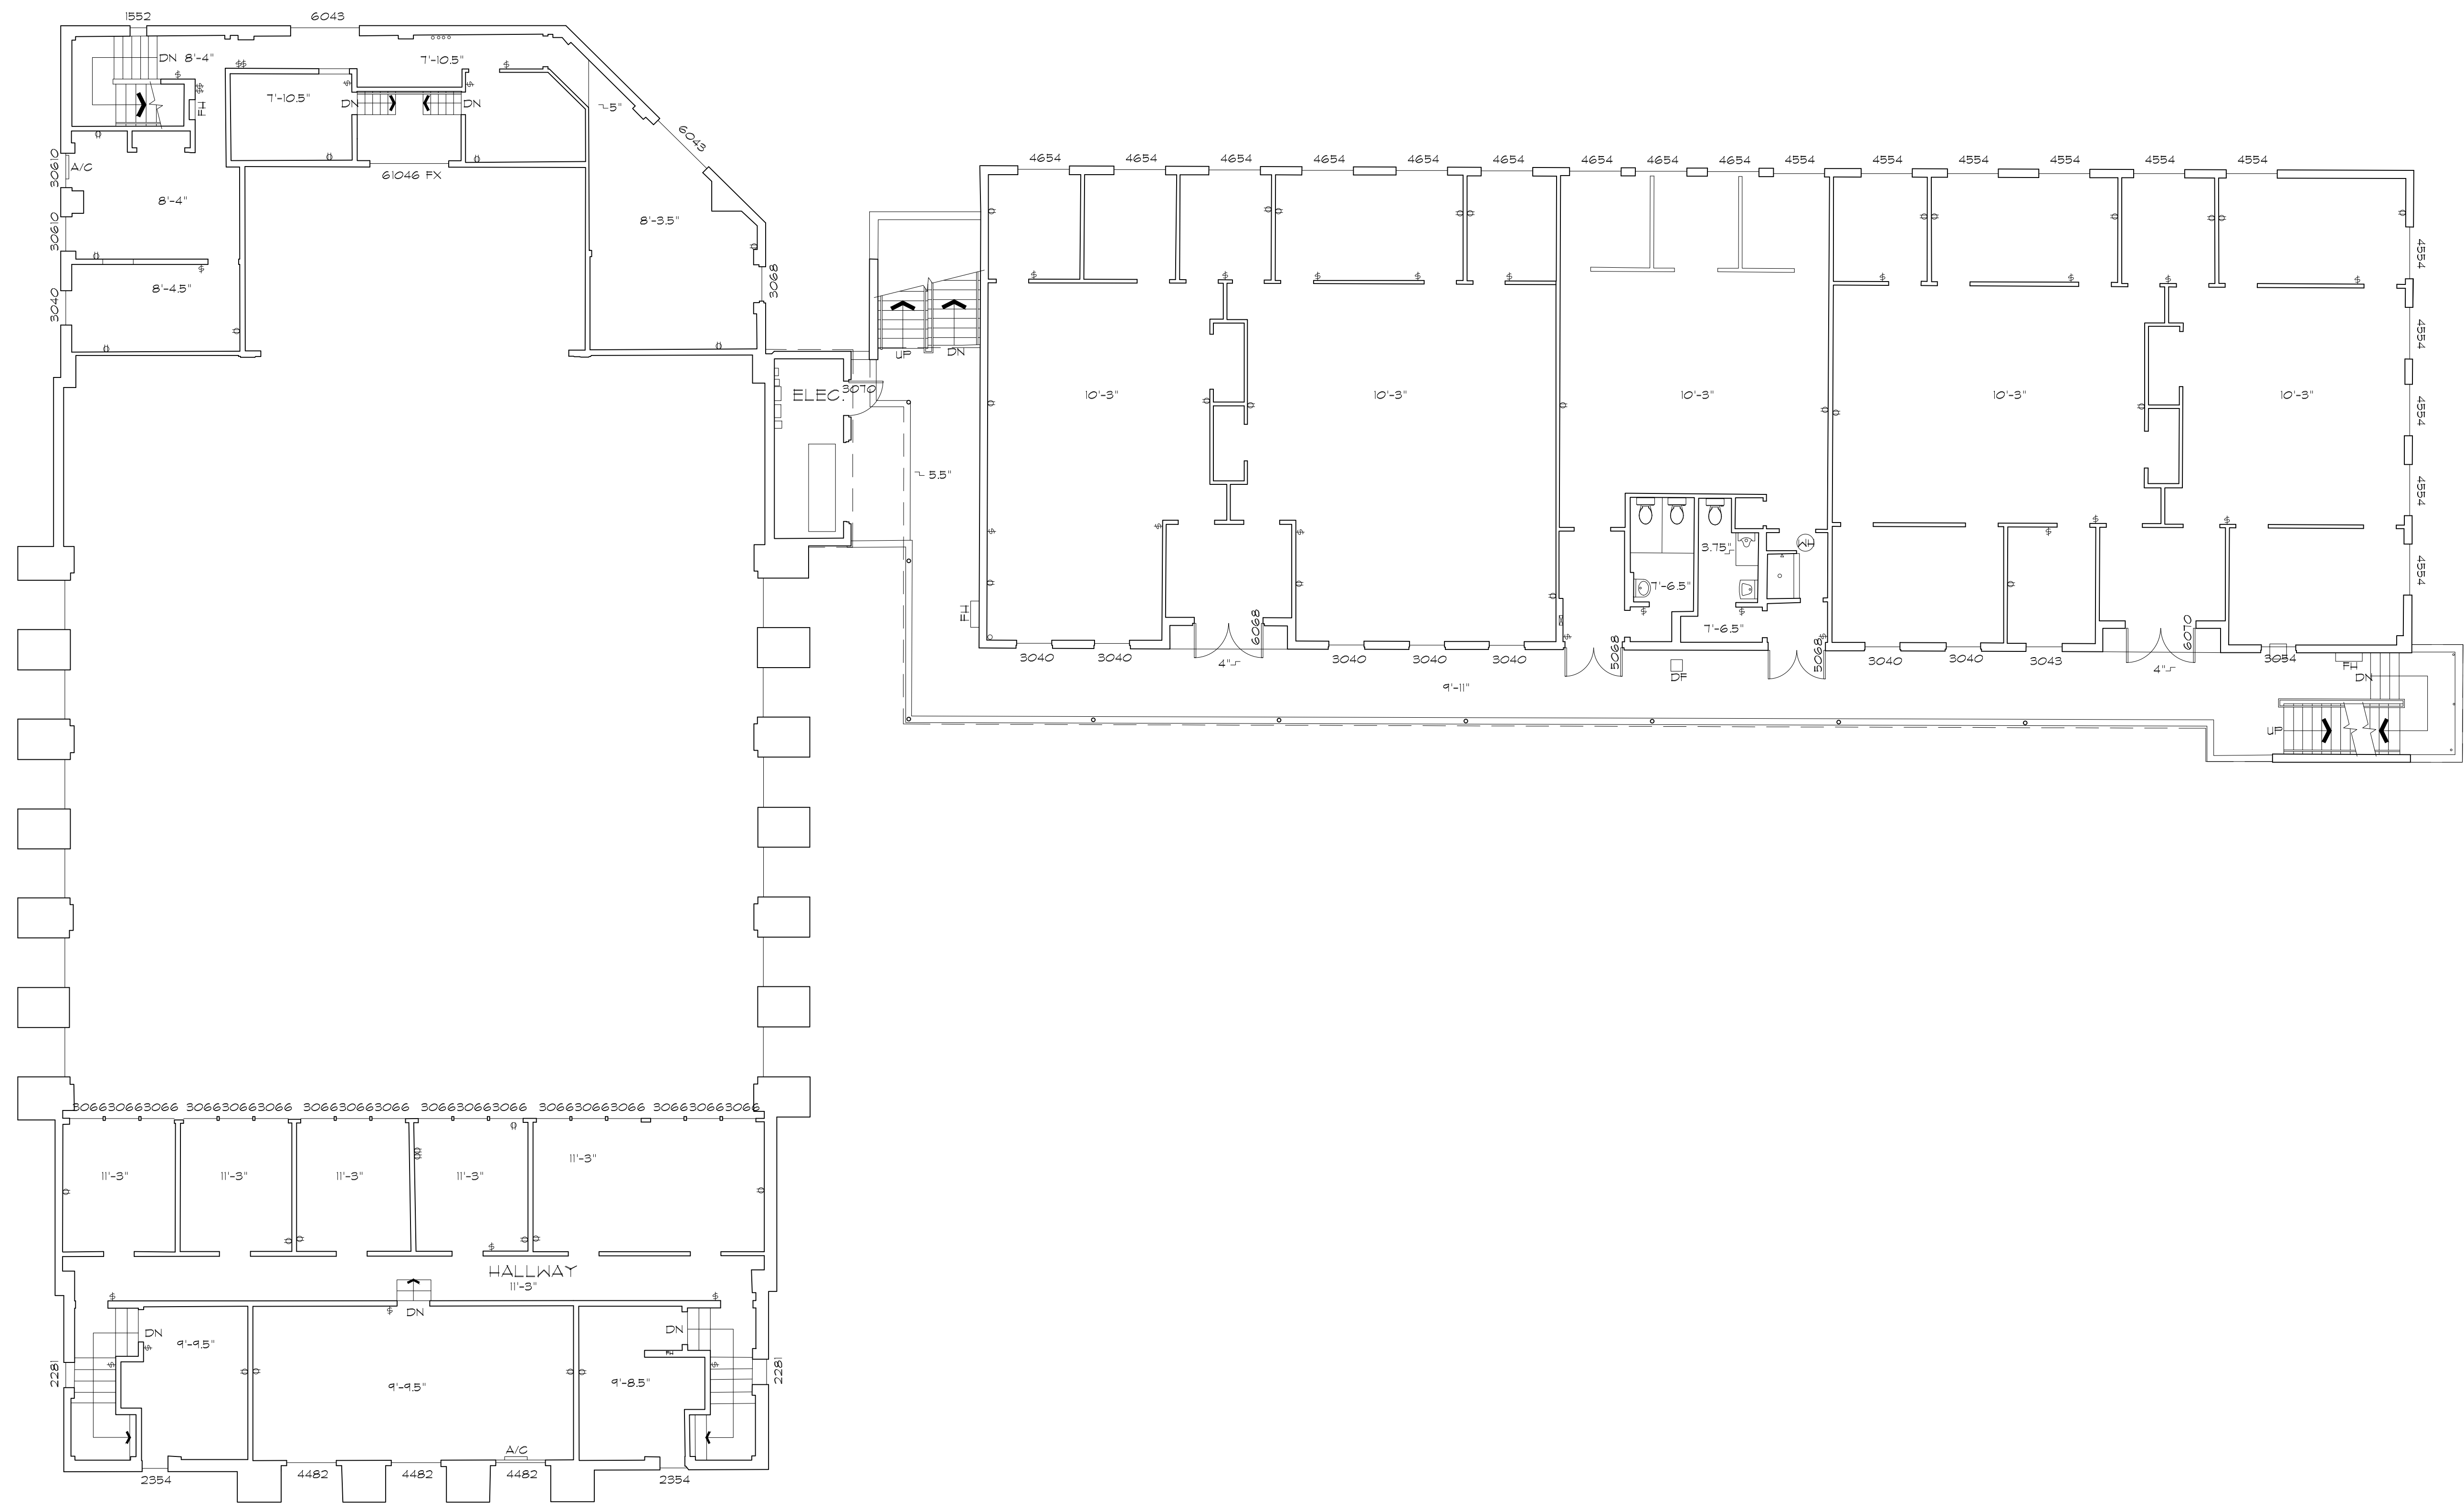

NOTE: ALL WINDOWS ARE JALOUSIE UNLESS OTHERWISE NOTED

01	100% SUBMISSION	SEE COVER SHEET
NO.	ISSUES   REVISIONS	DATE
SHEET TITLE		
<b>SECOND FLOOR PLAN</b>		
HL	PROJECT MANAGER	
HL	PROJECT DIRECTOR	
012317-1	PROJECT NUMBER	
<b>1/8"=1'-0"</b>	SCALE	
CL	DRAWN BY	
	SHEET NUMBER	


**ARCHITECTURAL AS BUILT**  
**MIAMI, FL 33150**

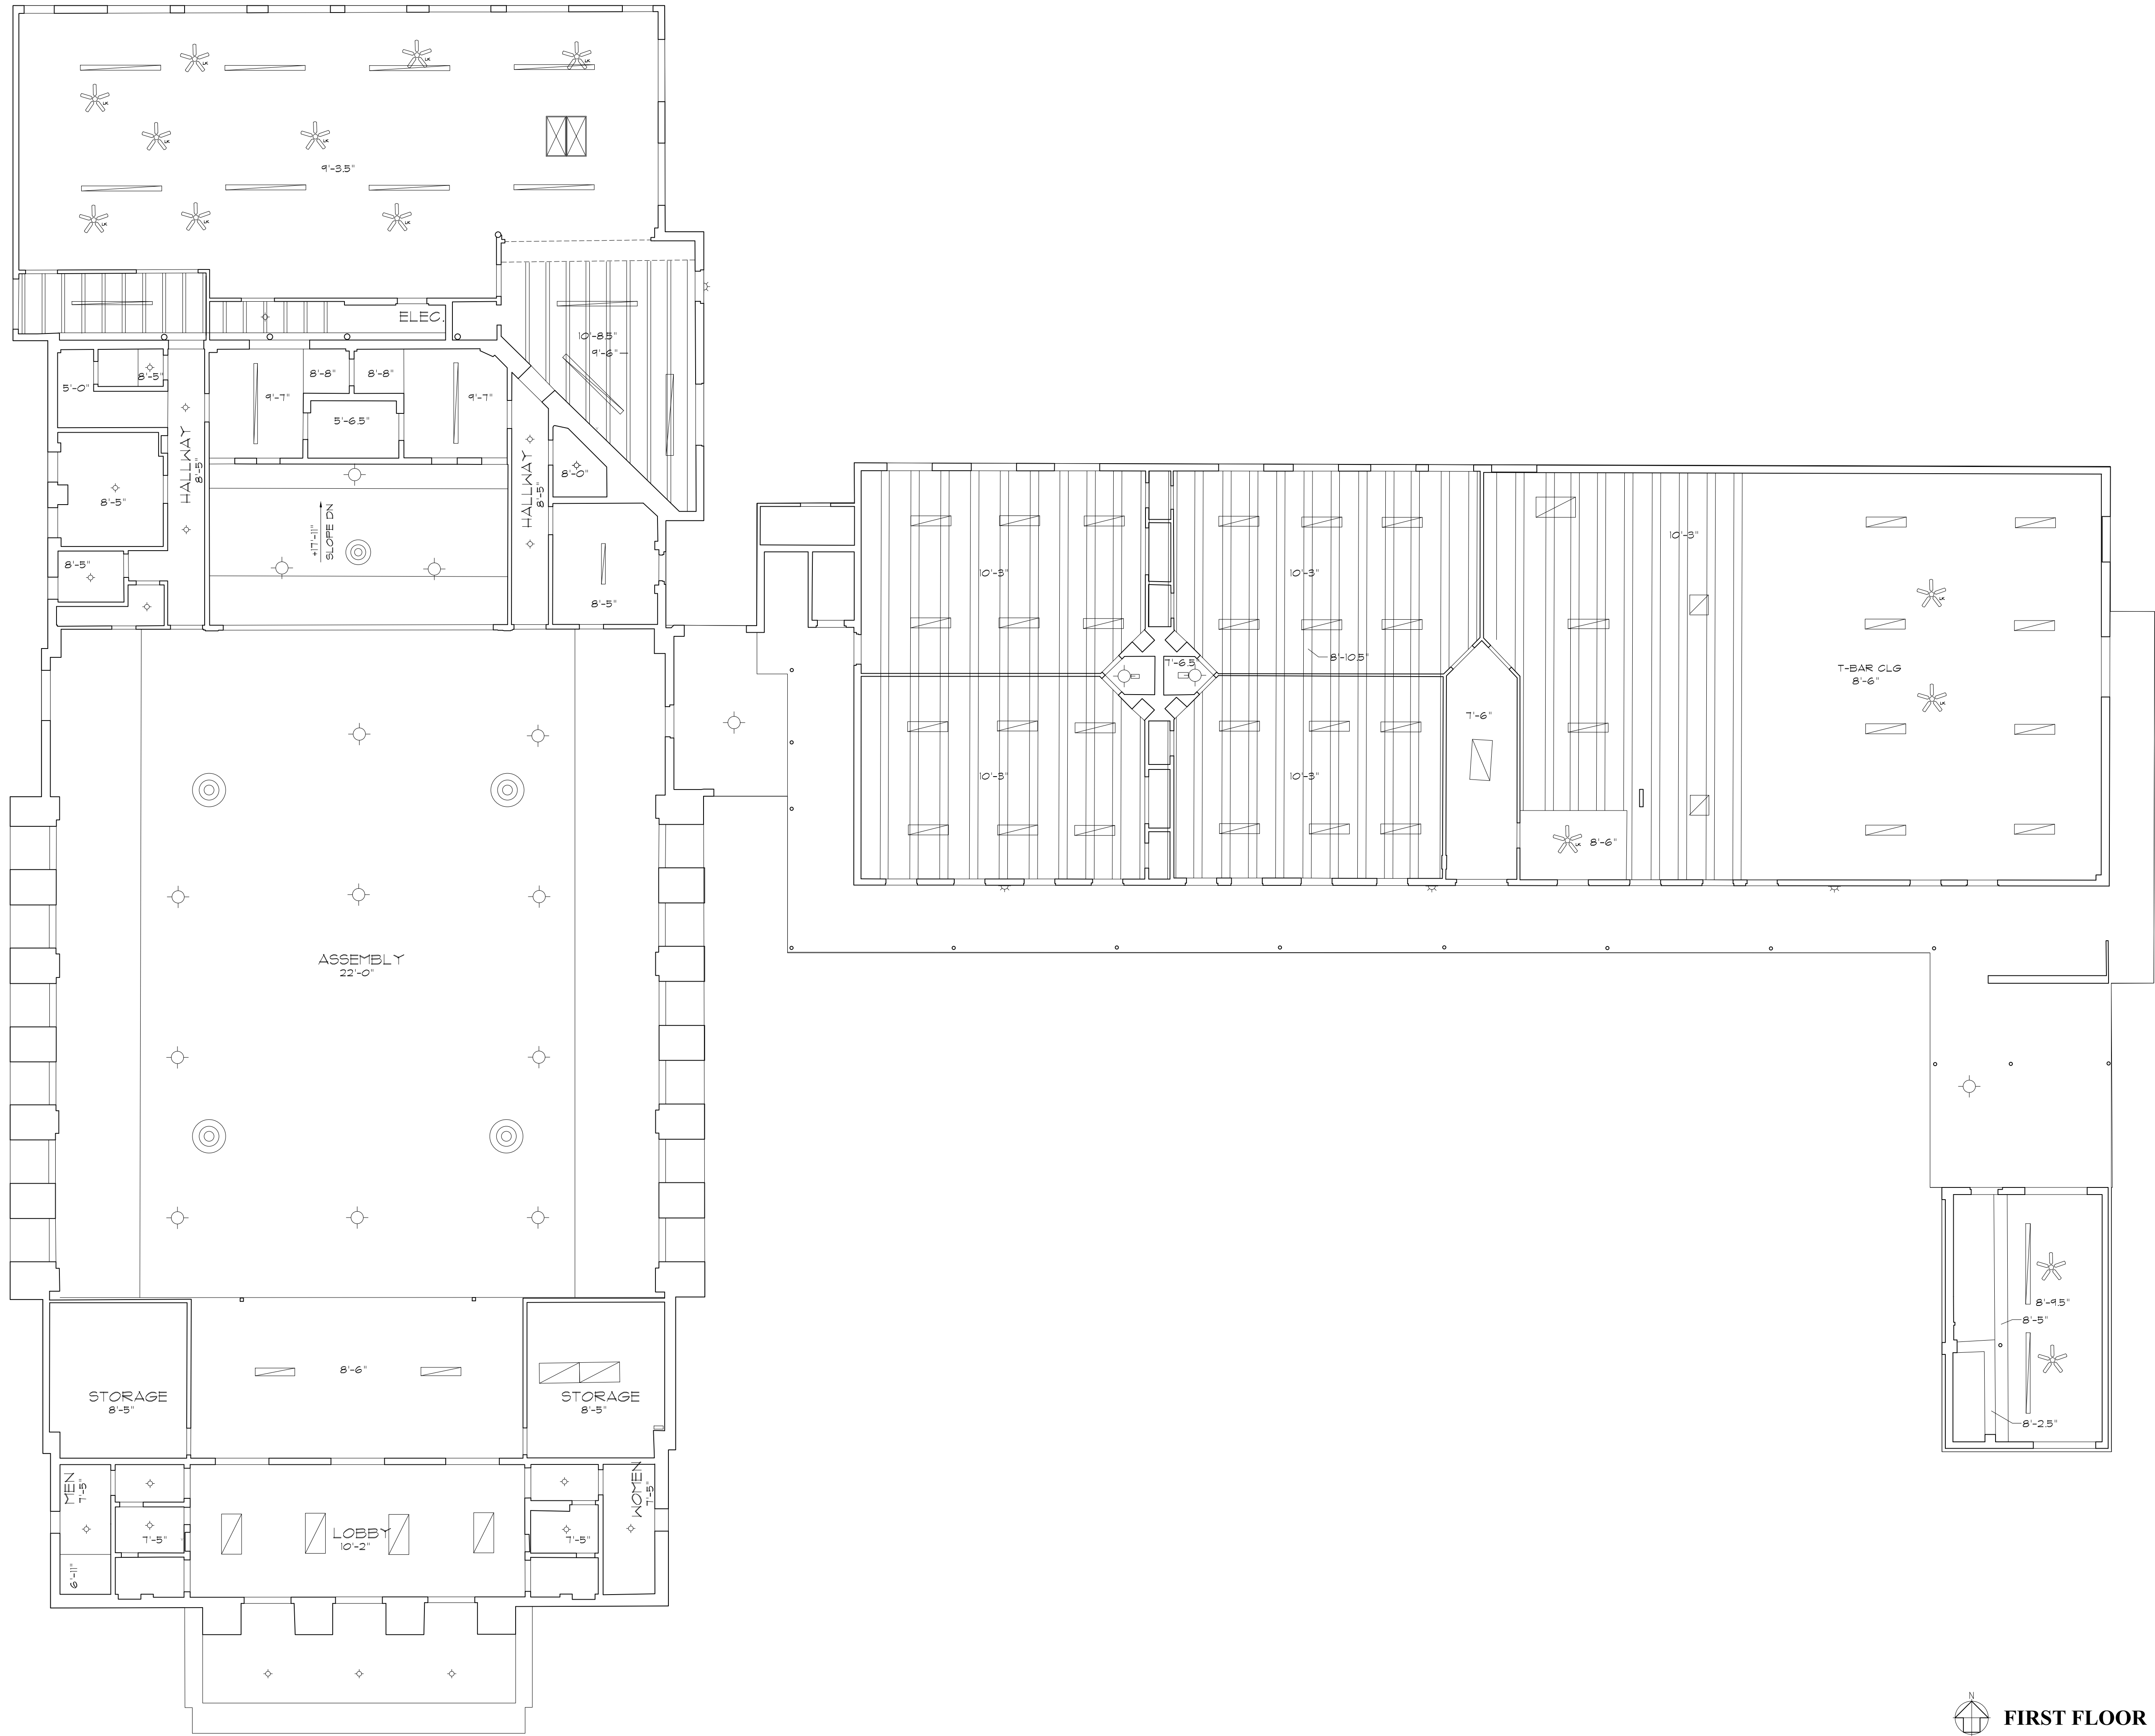


01	100% SUBMISSION	SEE COVER SHEET
NO.	ISSUES   REVISIONS	DATE
SHEET TITLE		

**REFLECTED CEILING PLAN**

HL	PROJECT MANAGER
HL	PROJECT DIRECTOR
012317-1	PROJECT NUMBER
1/8"=1'-0"	SCALE
CL	DRAWN BY
	SHEET NUMBER

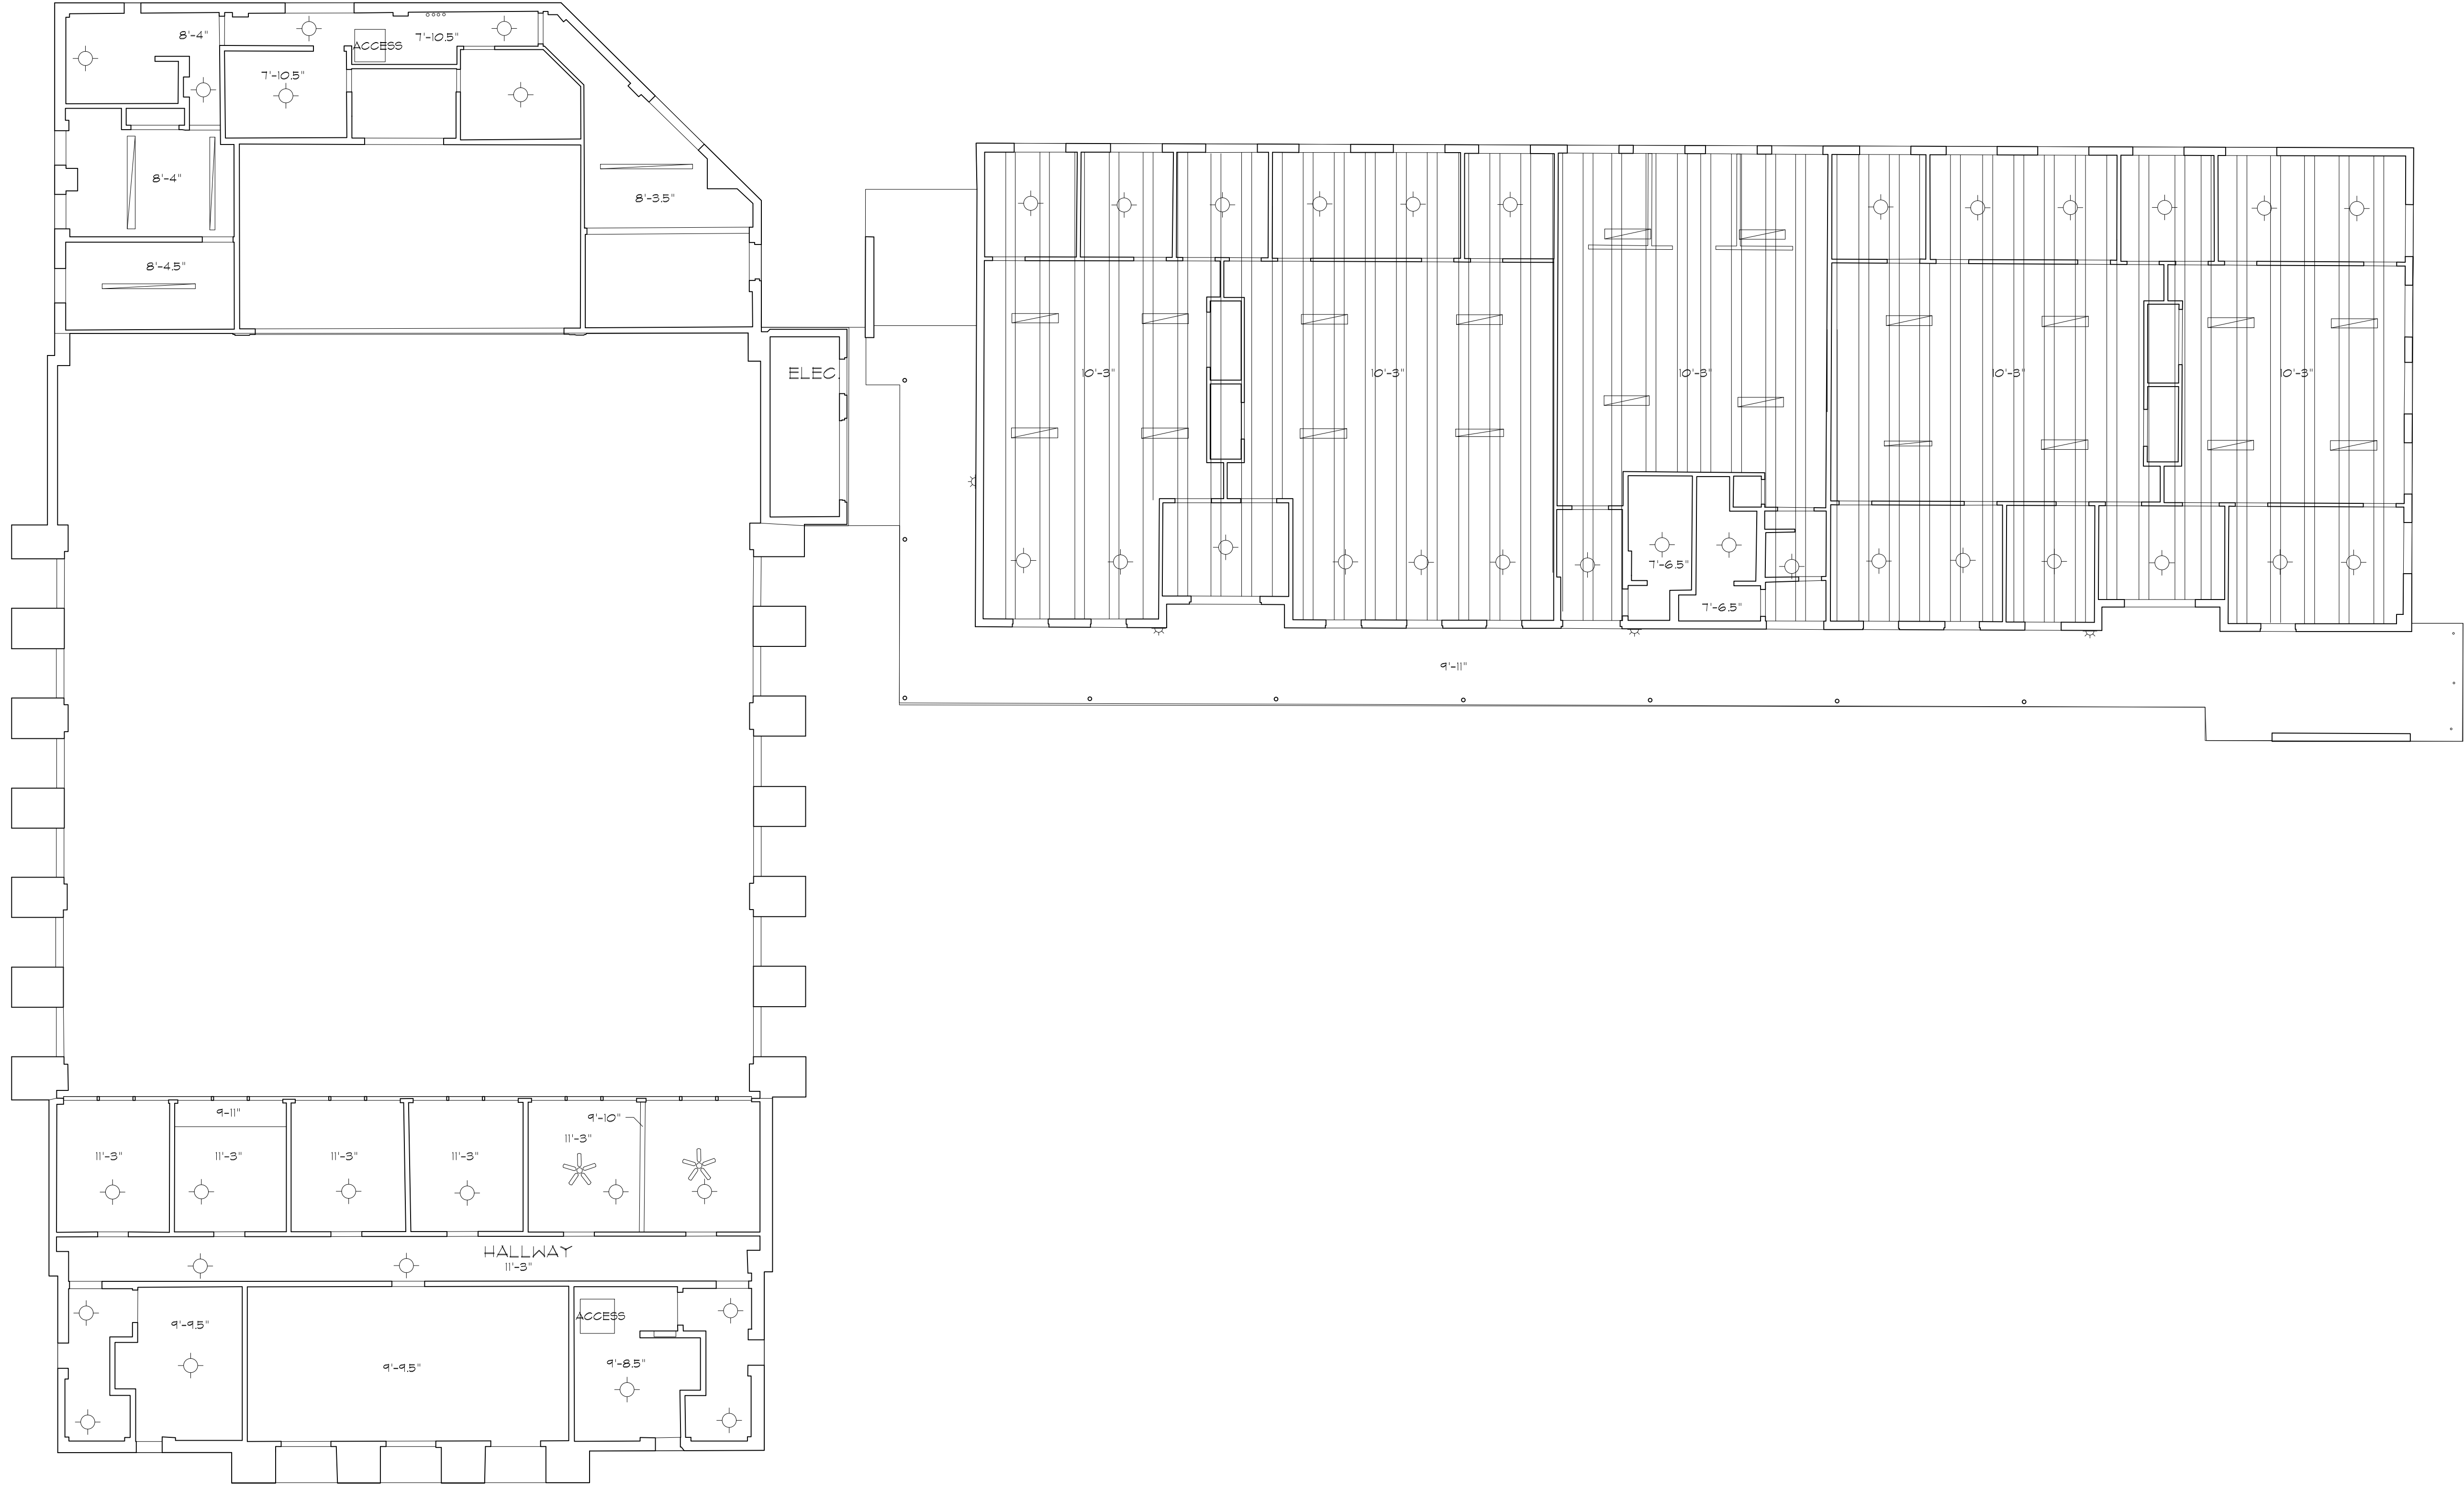

**ARCHITECTURAL AS BUILT**  
**MIAMI, FL 33150**

01	100% SUBMISSION	SEE COVER SHEET
NO.	ISSUES   REVISIONS	DATE
SHEET TITLE		

**REFLECTED CEILING PLAN**

HL	PROJECT MANAGER
HL	PROJECT DIRECTOR
012317-1	PROJECT NUMBER
1/8"=1'-0"	SCALE
CL	DRAWN BY
	SHEET NUMBER