

AS-BUILT DOCUMENTATION

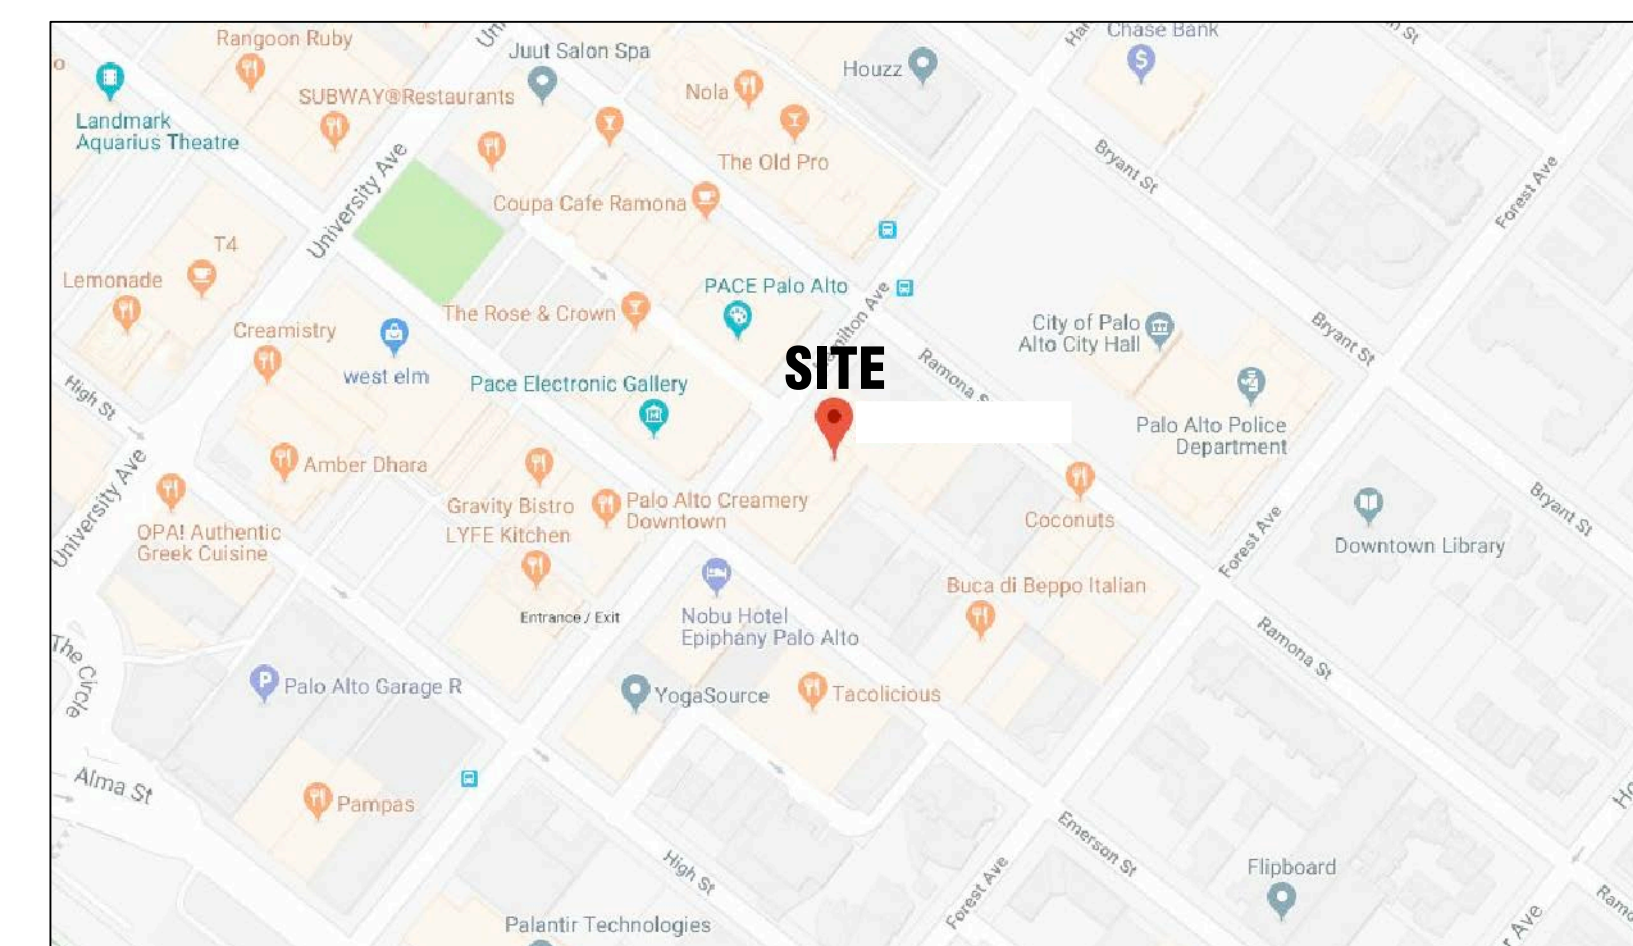
Commercial Office Building



100% SUBMITTAL

DRAWING INDEX

C-1	COVER SHEET DRAWING INDEX
SL	SYMBOLS LEGEND
AB-1	1ST FLOOR PLAN
AB-2	2ND FLOOR PLAN
AB-3	3RD FLOOR PLAN
AB-4	1ST FLOOR PHOTO PLAN
AB-5	2ND FLOOR PHOTO PLAN
AB-6	3RD FLOOR PHOTO PLAN



 VICINITY MAP
NTS

<u>AREA DATA</u>	
FIRST FLOOR	8,774 S.F.
SECOND FLOOR	9,050 S.F.
THIRD FLOOR	9,017 S.F.
GRAND TOTAL	26,841 S.F.



ARCHITECTURAL AS BUILT

Palo Alto, CA 94301

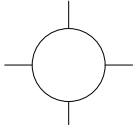
01	100% SUBMISSION	SEE COVER SHEET
NO.	ISSUES REVISIONS	DATE
		SHEET TITLE
COVER SHEET		
HL	PROJECT MANAGER	
HL	PROJECT DIRECTOR	
012317-1		PROJECT NUMBER
		SCALE
CL	DRAWN BY	
		SHEET NUMBER

 
C-1

SYMBOLS LEGEND

RCP

- 

 
EXHAUST VENT
- 

 
CEILING MOUNTED LIGHT FIXTURE
- 

 
CEILING MOUNTED DIRECTIONAL LIGHT
- 

RECESSED CAN LIGHT
- 

EYEBALL OR SMALL CAN LIGHT
- 

PENDANT LIGHT
- 

INDIVIDUAL FLUOR. LAY-IN FIXTURE 4 BULB
- 

INDIVIDUAL FLUOR. HANGING FIXTURE 2 BULB
- 

 
INDIVIDUAL FLUOR. FLUSH MOUNT FIXTURE 4 BULB
- 

CAMERA
- 

MOTION DET.
- 

 
SUPPLY VENT
- 

SUPPLY VENT
- 

RETURN VENT
- 

 
RETURN VENT
- 

 
SPEAKER

- 

 
TRACK LIGHT OR VANITY LIGHT
- 

WALL-MOUNTED LIGHT FIXTURE
- 

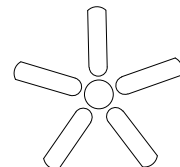
EMERGENCY EXIT SIGN
- 

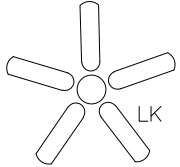
EMERGENCY EXIT LIGHT
- 

EMERGENCY EXIT LIGHT W/ SIGN
- 

LIGHTED STAIR SIGN
- 

FLOOD LIGHT
- 

PC PHOTO CELL
- 

CEILING FAN
- 

CEILING FAN W/ LIGHT KIT
- 7-2-6

CEILING HEIGHT AND TRIM 7'-2" ABOVE FLOOR BELOW WITH 6" CROWN MOULDING. NOTE: ALL CEILINGS NOT LABELED ARE PLASTER. CEILINGS SHOWN WITH A GRID ARE LAY IN ACOUSTICAL TILE..
- 

JUNCTION BOX

ELECTRIC

- 

DATA OUTLET
- 

TELEPHONE JACK
- 

 
ELECTRIC SWITCH
- 

CABLE TELEVISION OUTLET
- 

DUPLEX RECEPTACLE OUTLET
- 

SPECIAL PURPOSE CONNECTION OR OUTLET
- 

QUADRUPLEX RECEPTACLE OUTLET
- 

FLOOR DUPLEX RECEPTACLE OUTLET
- 

ELECTRIC PANEL
- 

ELECTRIC METER
- 

BUTTON SWITCH
- 

DISCONNECT SWITCH
- 

GROUND/FLOOR LIGHT
- 

KEY PAD

FIRE PROTECTION

- 

FIRE EXTINGUISHER
- 

FIRE PULL
- 

FIRE ALARM (HORN/SRTO)
- 

SMOKE DETECTOR
- 

SMOKE ALARM SPEAKER
- 

SPRINKLER HEAD CEILING MOUNT
- 

SPRINKLER HEAD WALL MOUNT

MEP

- 

THERMOSTAT
- 

FLOOR DRAIN
- 

VALVE
- 

HOSE BIB
- 

WATER SUPPLY
- 

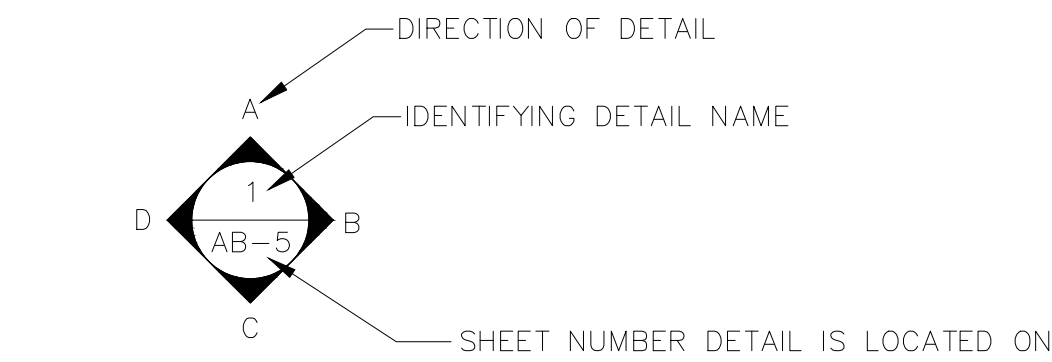
SUSPENDED GAS HEATER

MISC

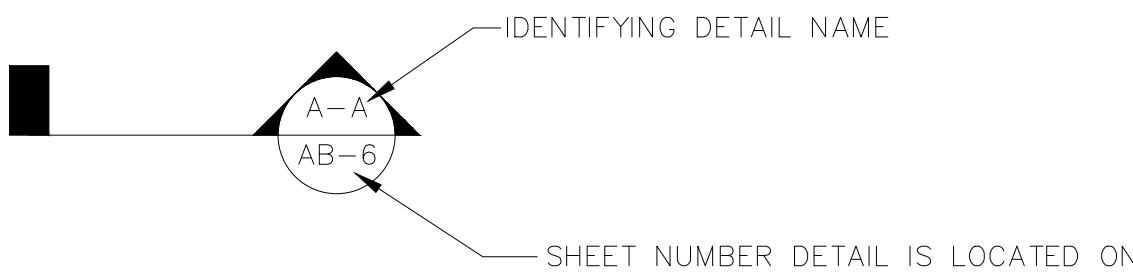
- 

BOLLARD
- 

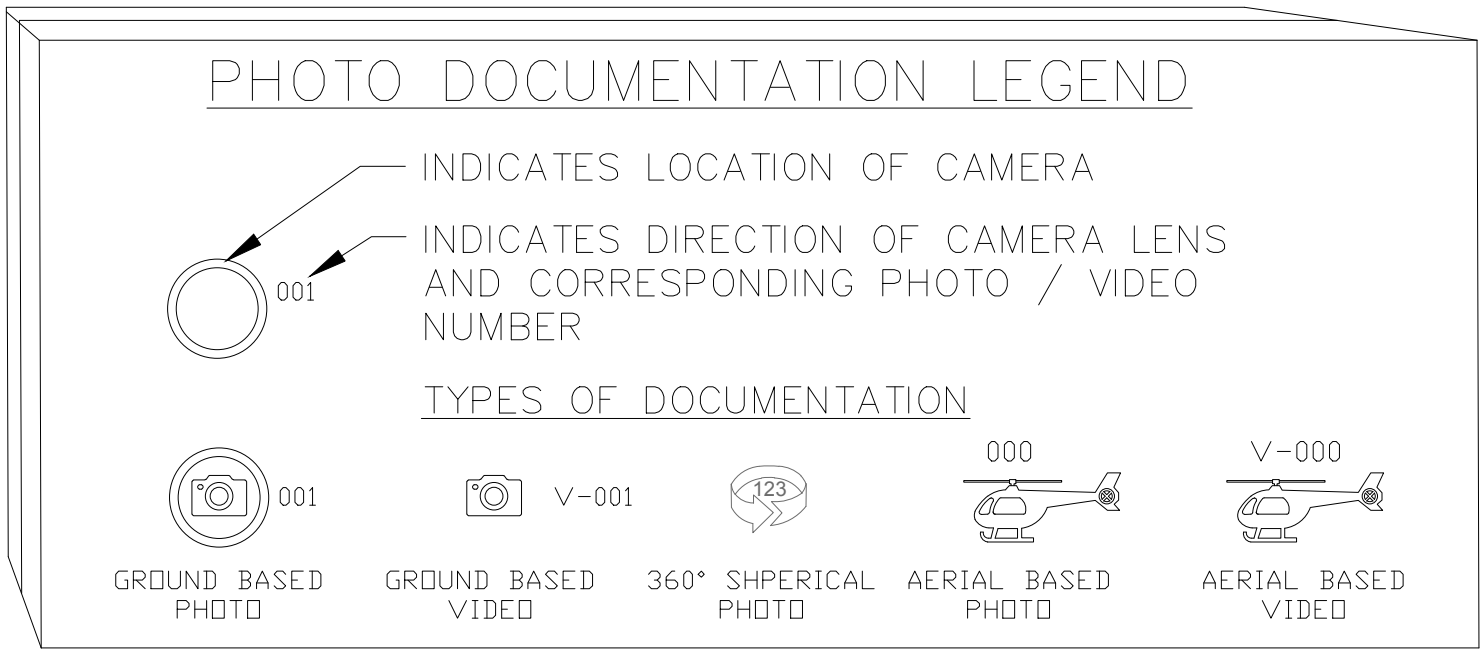
11-4-11/16 SPOT ELEVATION



INTERIOR ELEVATIONS



BUILDING SECTION



AS BUILT
PROFESSIONALS
www.asbuiltprofessionals.com

A DIVISION OF:



© 2017 AEC CONSULTANTS INC.

ARCHITECTURAL AS BUILT

Palo Alto, CA 94301

01	100% SUBMISSION	SEE COVER SHEET
NO.	ISSUES REVISIONS	DATE
		SHEET TITLE
HL	PROJECT MANAGER	
HL	PROJECT DIRECTOR	
012317-1	PROJECT NUMBER	
NOT TO SCALE		SCALE
CL	DRAWN BY	
		SHEET NUMBER

SL

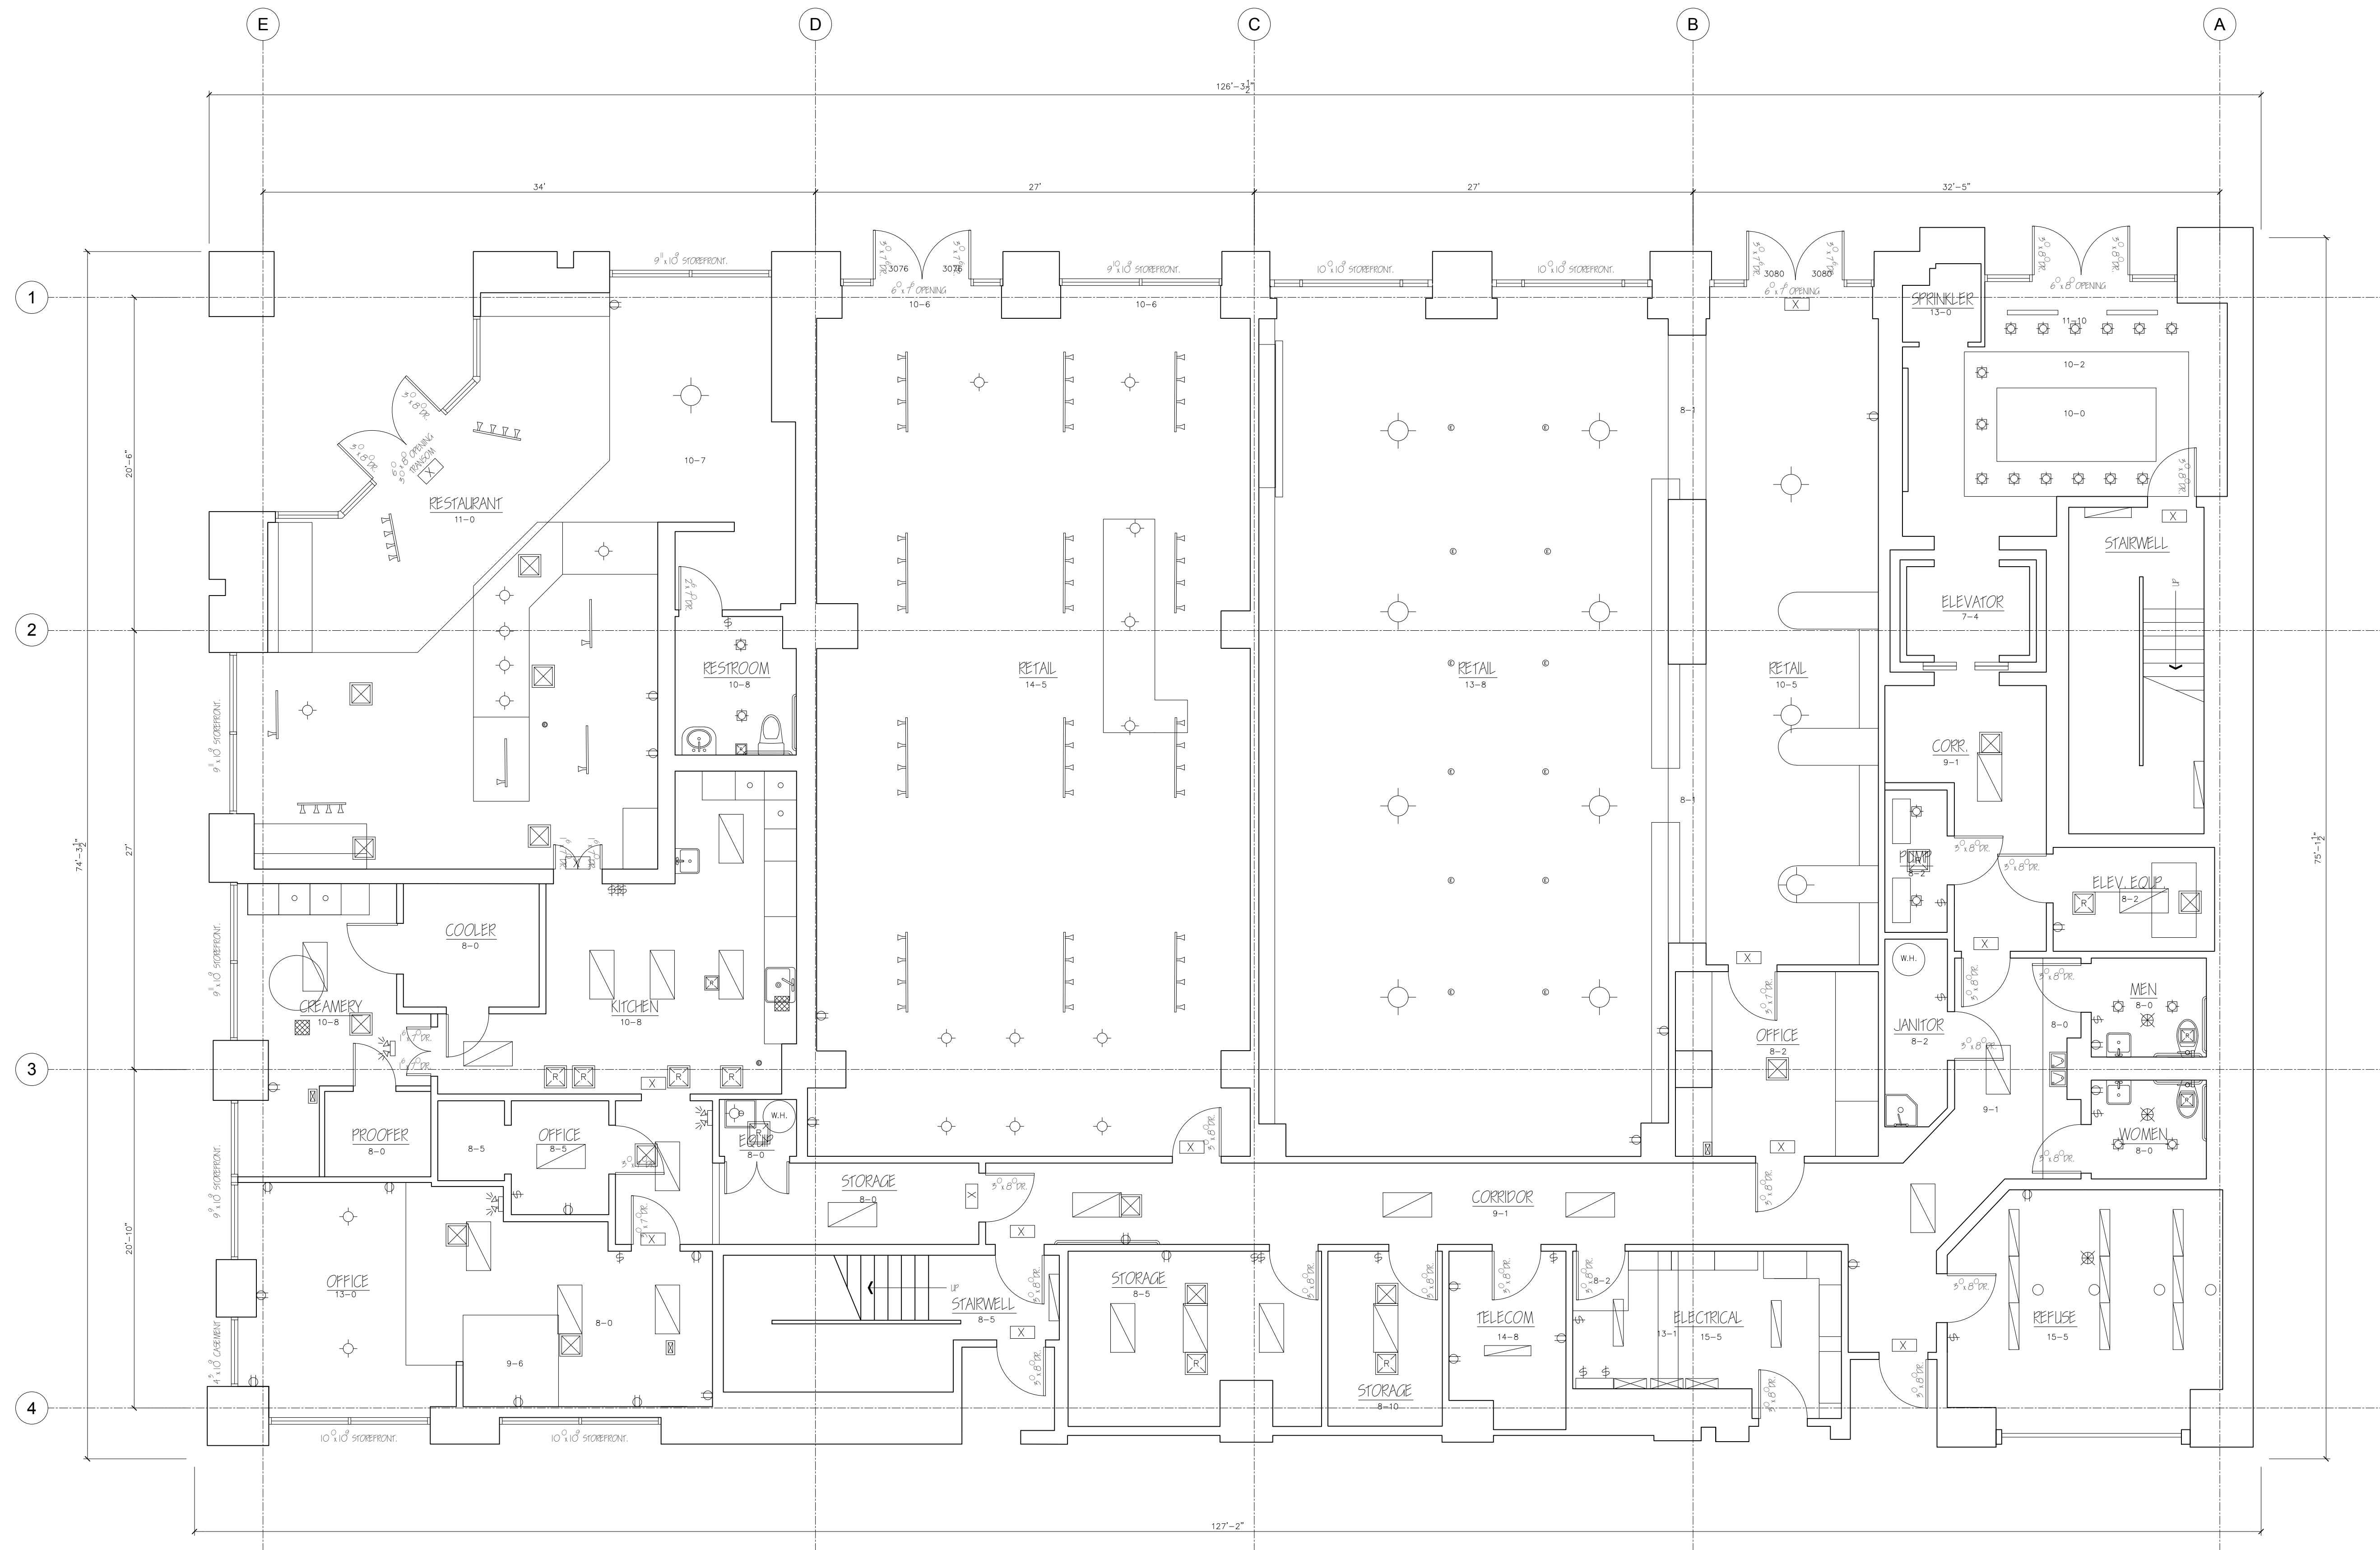
ARCHITECTURAL AS BUILT

Palo Alto, CA 94301

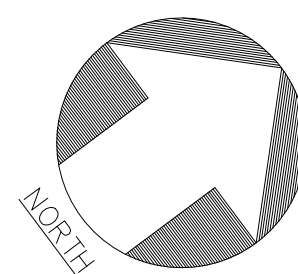
01	100% SUBMISSION	SEE COVER SHEET
NO.	ISSUES REVISIONS	DATE
SHEET TITLE		

HL	PROJECT MANAGER
HL	PROJECT DIRECTOR
012317-1	PROJECT NUMBER
3/16"=1'-0"	SCALE
CL	DRAWN BY
	SHEET NUMBER

AB-1



FIRST FLOOR PLAN



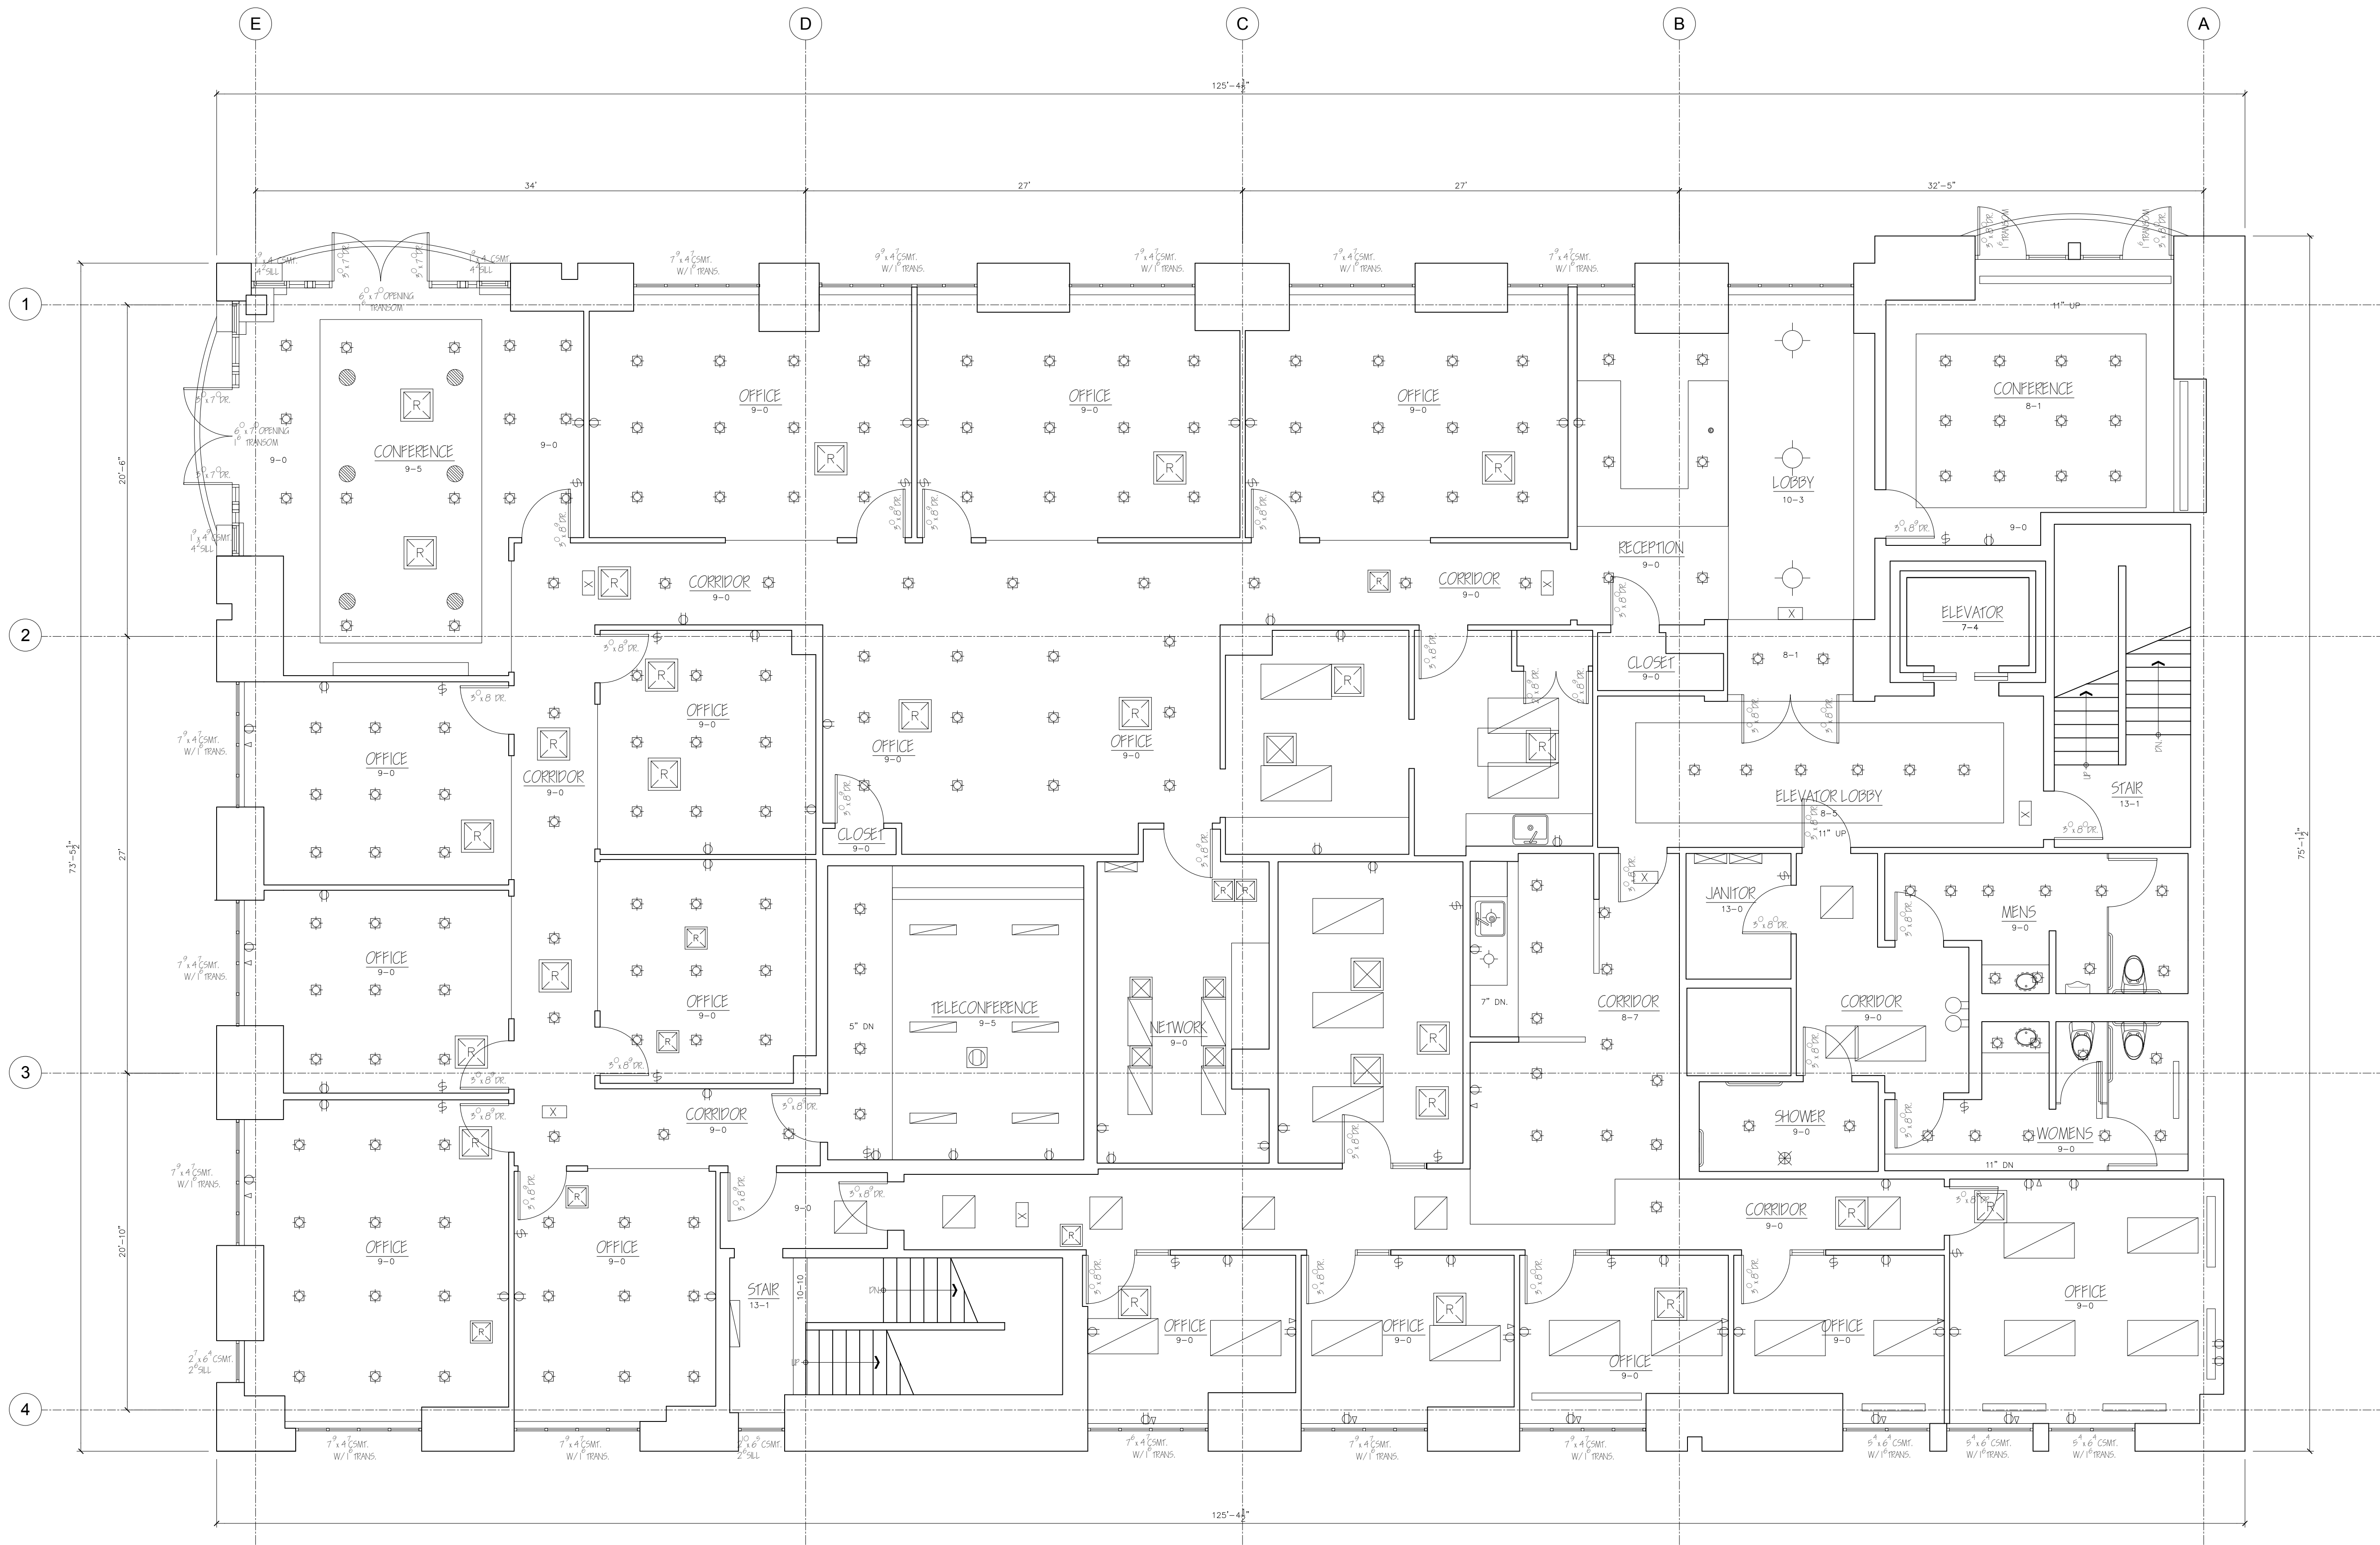
ARCHITECTURAL AS BUILT

Palo Alto, CA 94301

01	100% SUBMISSION	SEE COVER SHEET
NO.	ISSUES REVISIONS	DATE
SHEET TITLE		

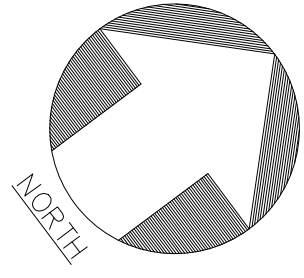
HL	PROJECT MANAGER
HL	PROJECT DIRECTOR
012317-1	PROJECT NUMBER
3/16"=1'-0"	SCALE
CL	DRAWN BY
SHEET NUMBER	

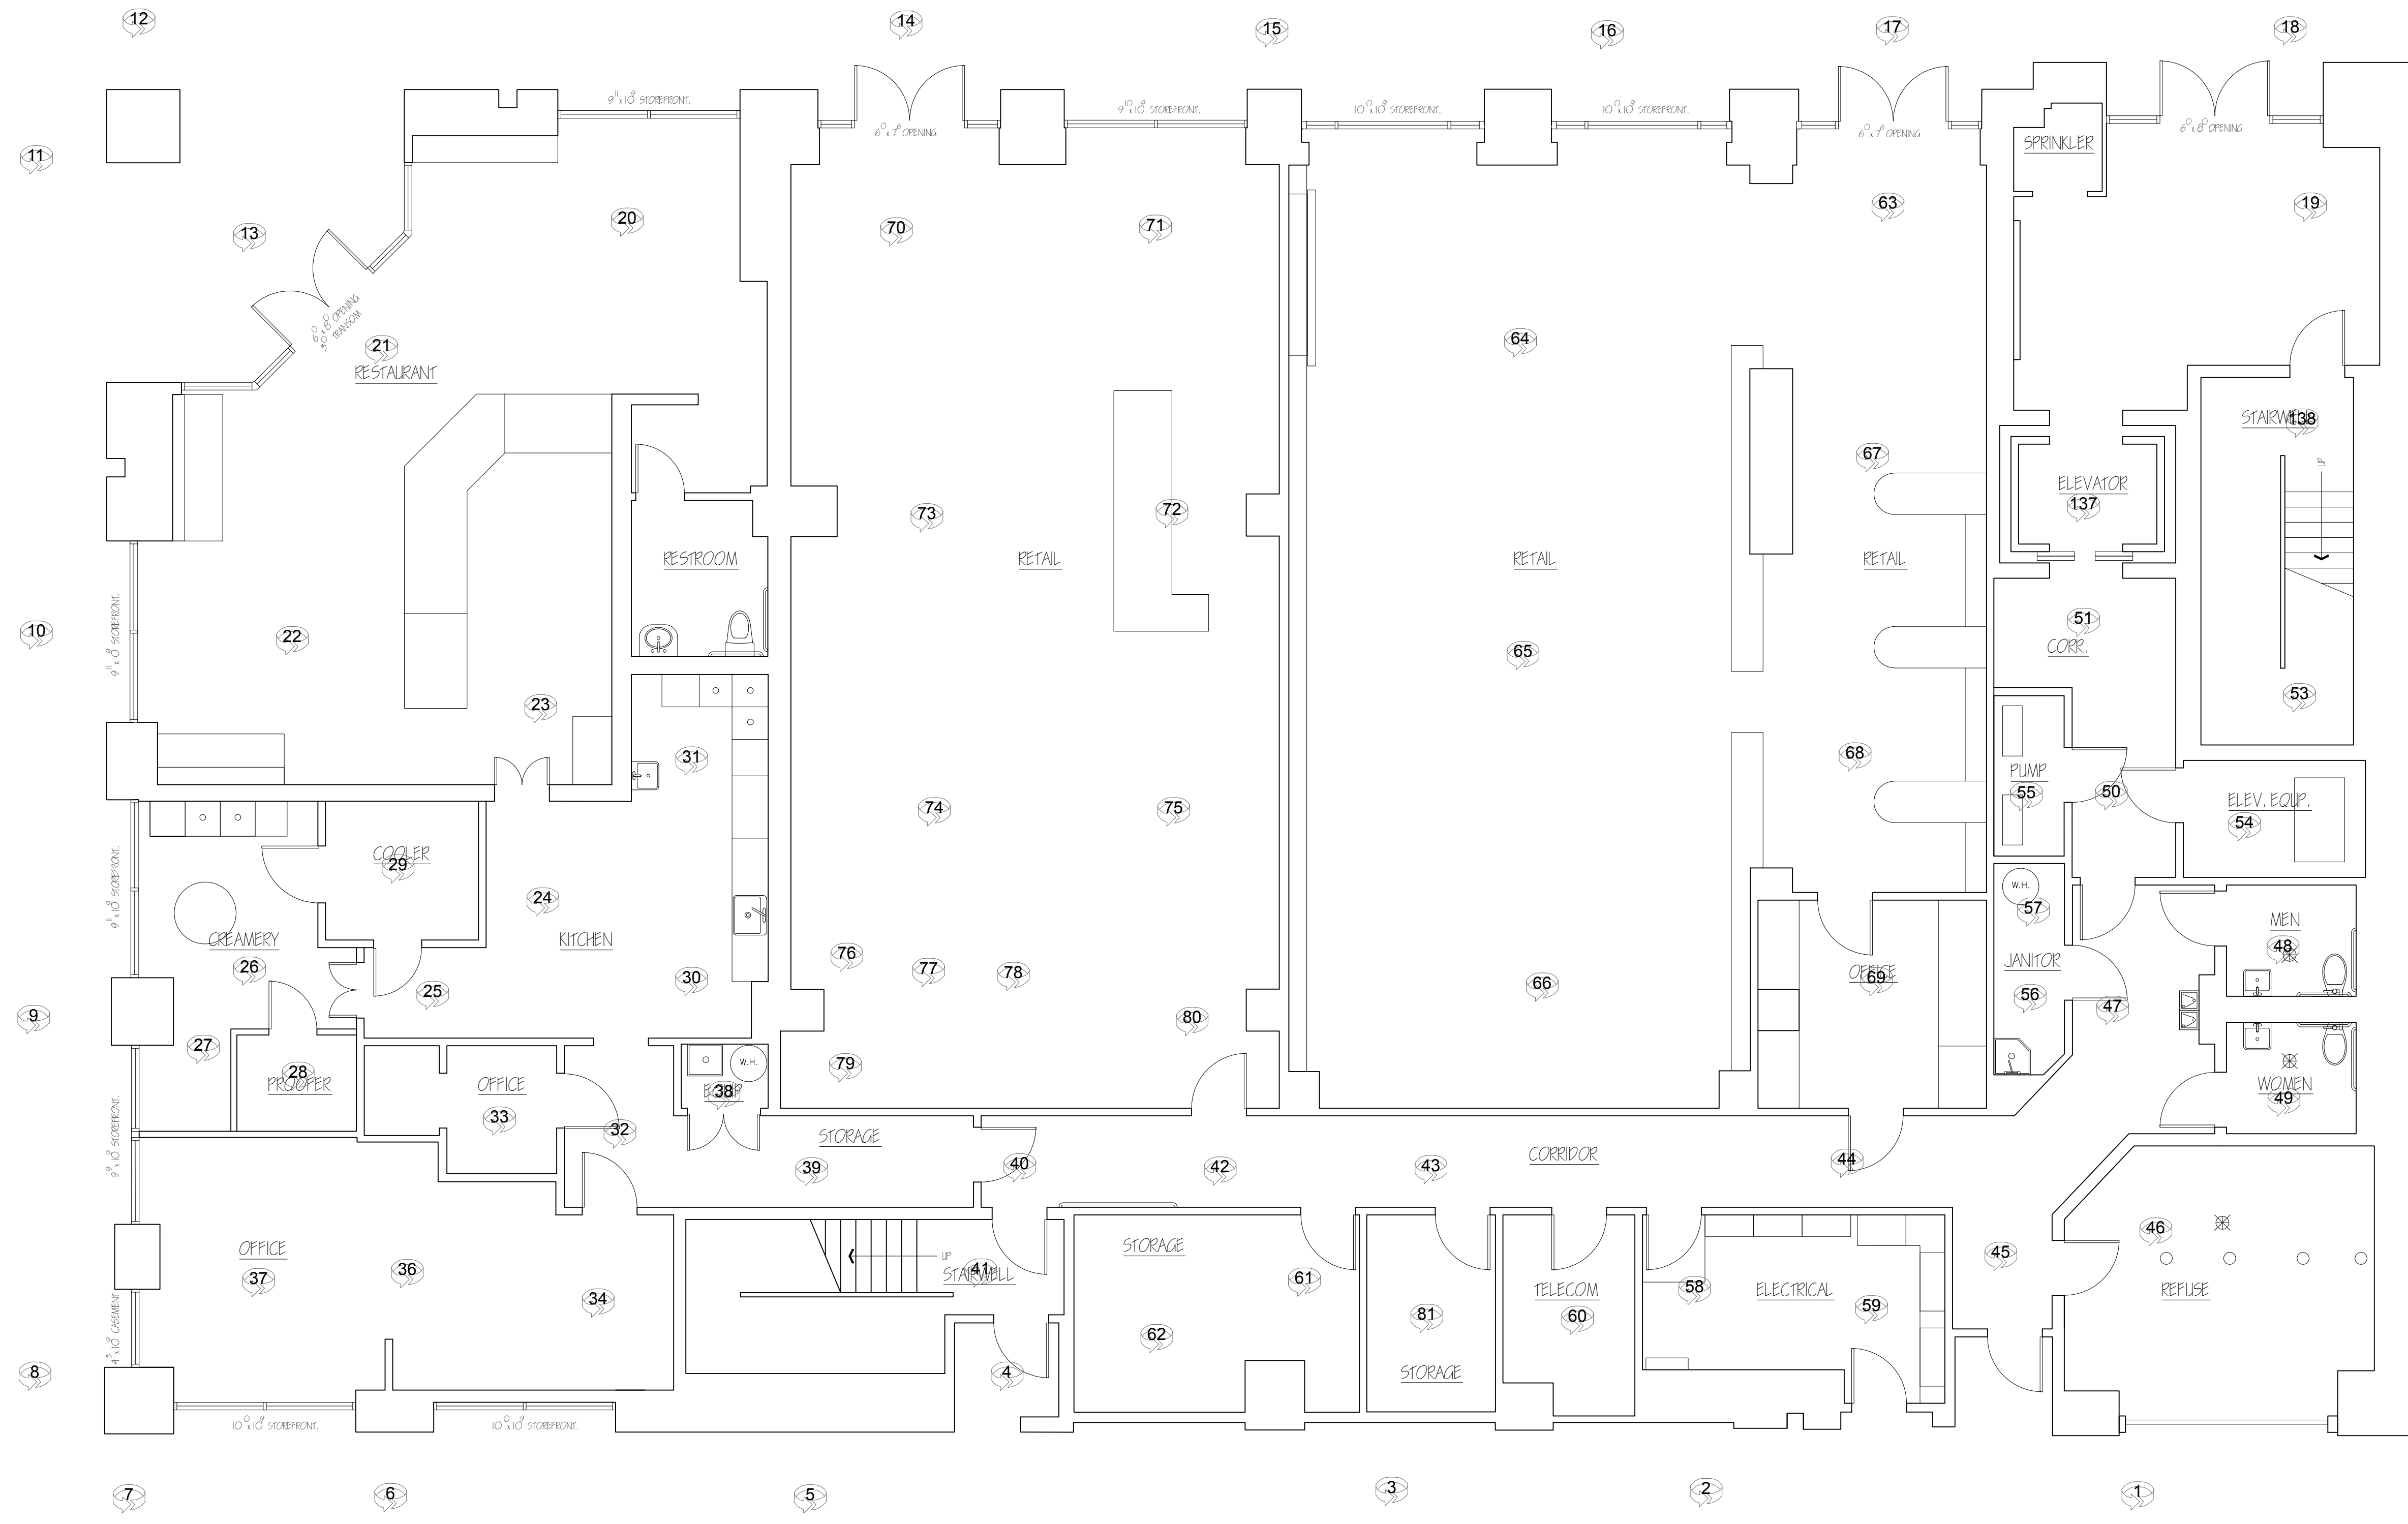
AB-2



SECOND FLOOR PLAN

15'-8" FF





FIRST FLOOR PLAN

PHOTO DOCUMENTATION LEGEND

INDICATES LOCATION OF CAMERA

INDICATES DIRECTION OF CAMERA LENS AND CORRESPONDING PHOTO / VIDEO NUMBER

TYPES OF DOCUMENTATION

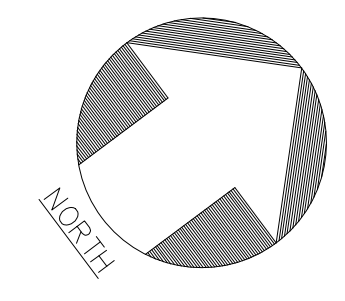
001 GROUND BASED PHOTO

V-001 GROUND BASED VIDEO

000 360° SPHERICAL PHOTO

000 AERIAL BASED PHOTO

V-000 AERIAL BASED VIDEO



AS BUILT PROFESSIONALS
www.asbuiltprofessionals.com
A DIVISION OF:

AEC CONSULTANTS INC

844.272.8458
844 AS BUILT

© 2017 AEC CONSULTANTS INC.

ARCHITECTURAL AS BUILT

Palo Alto, CA 94301

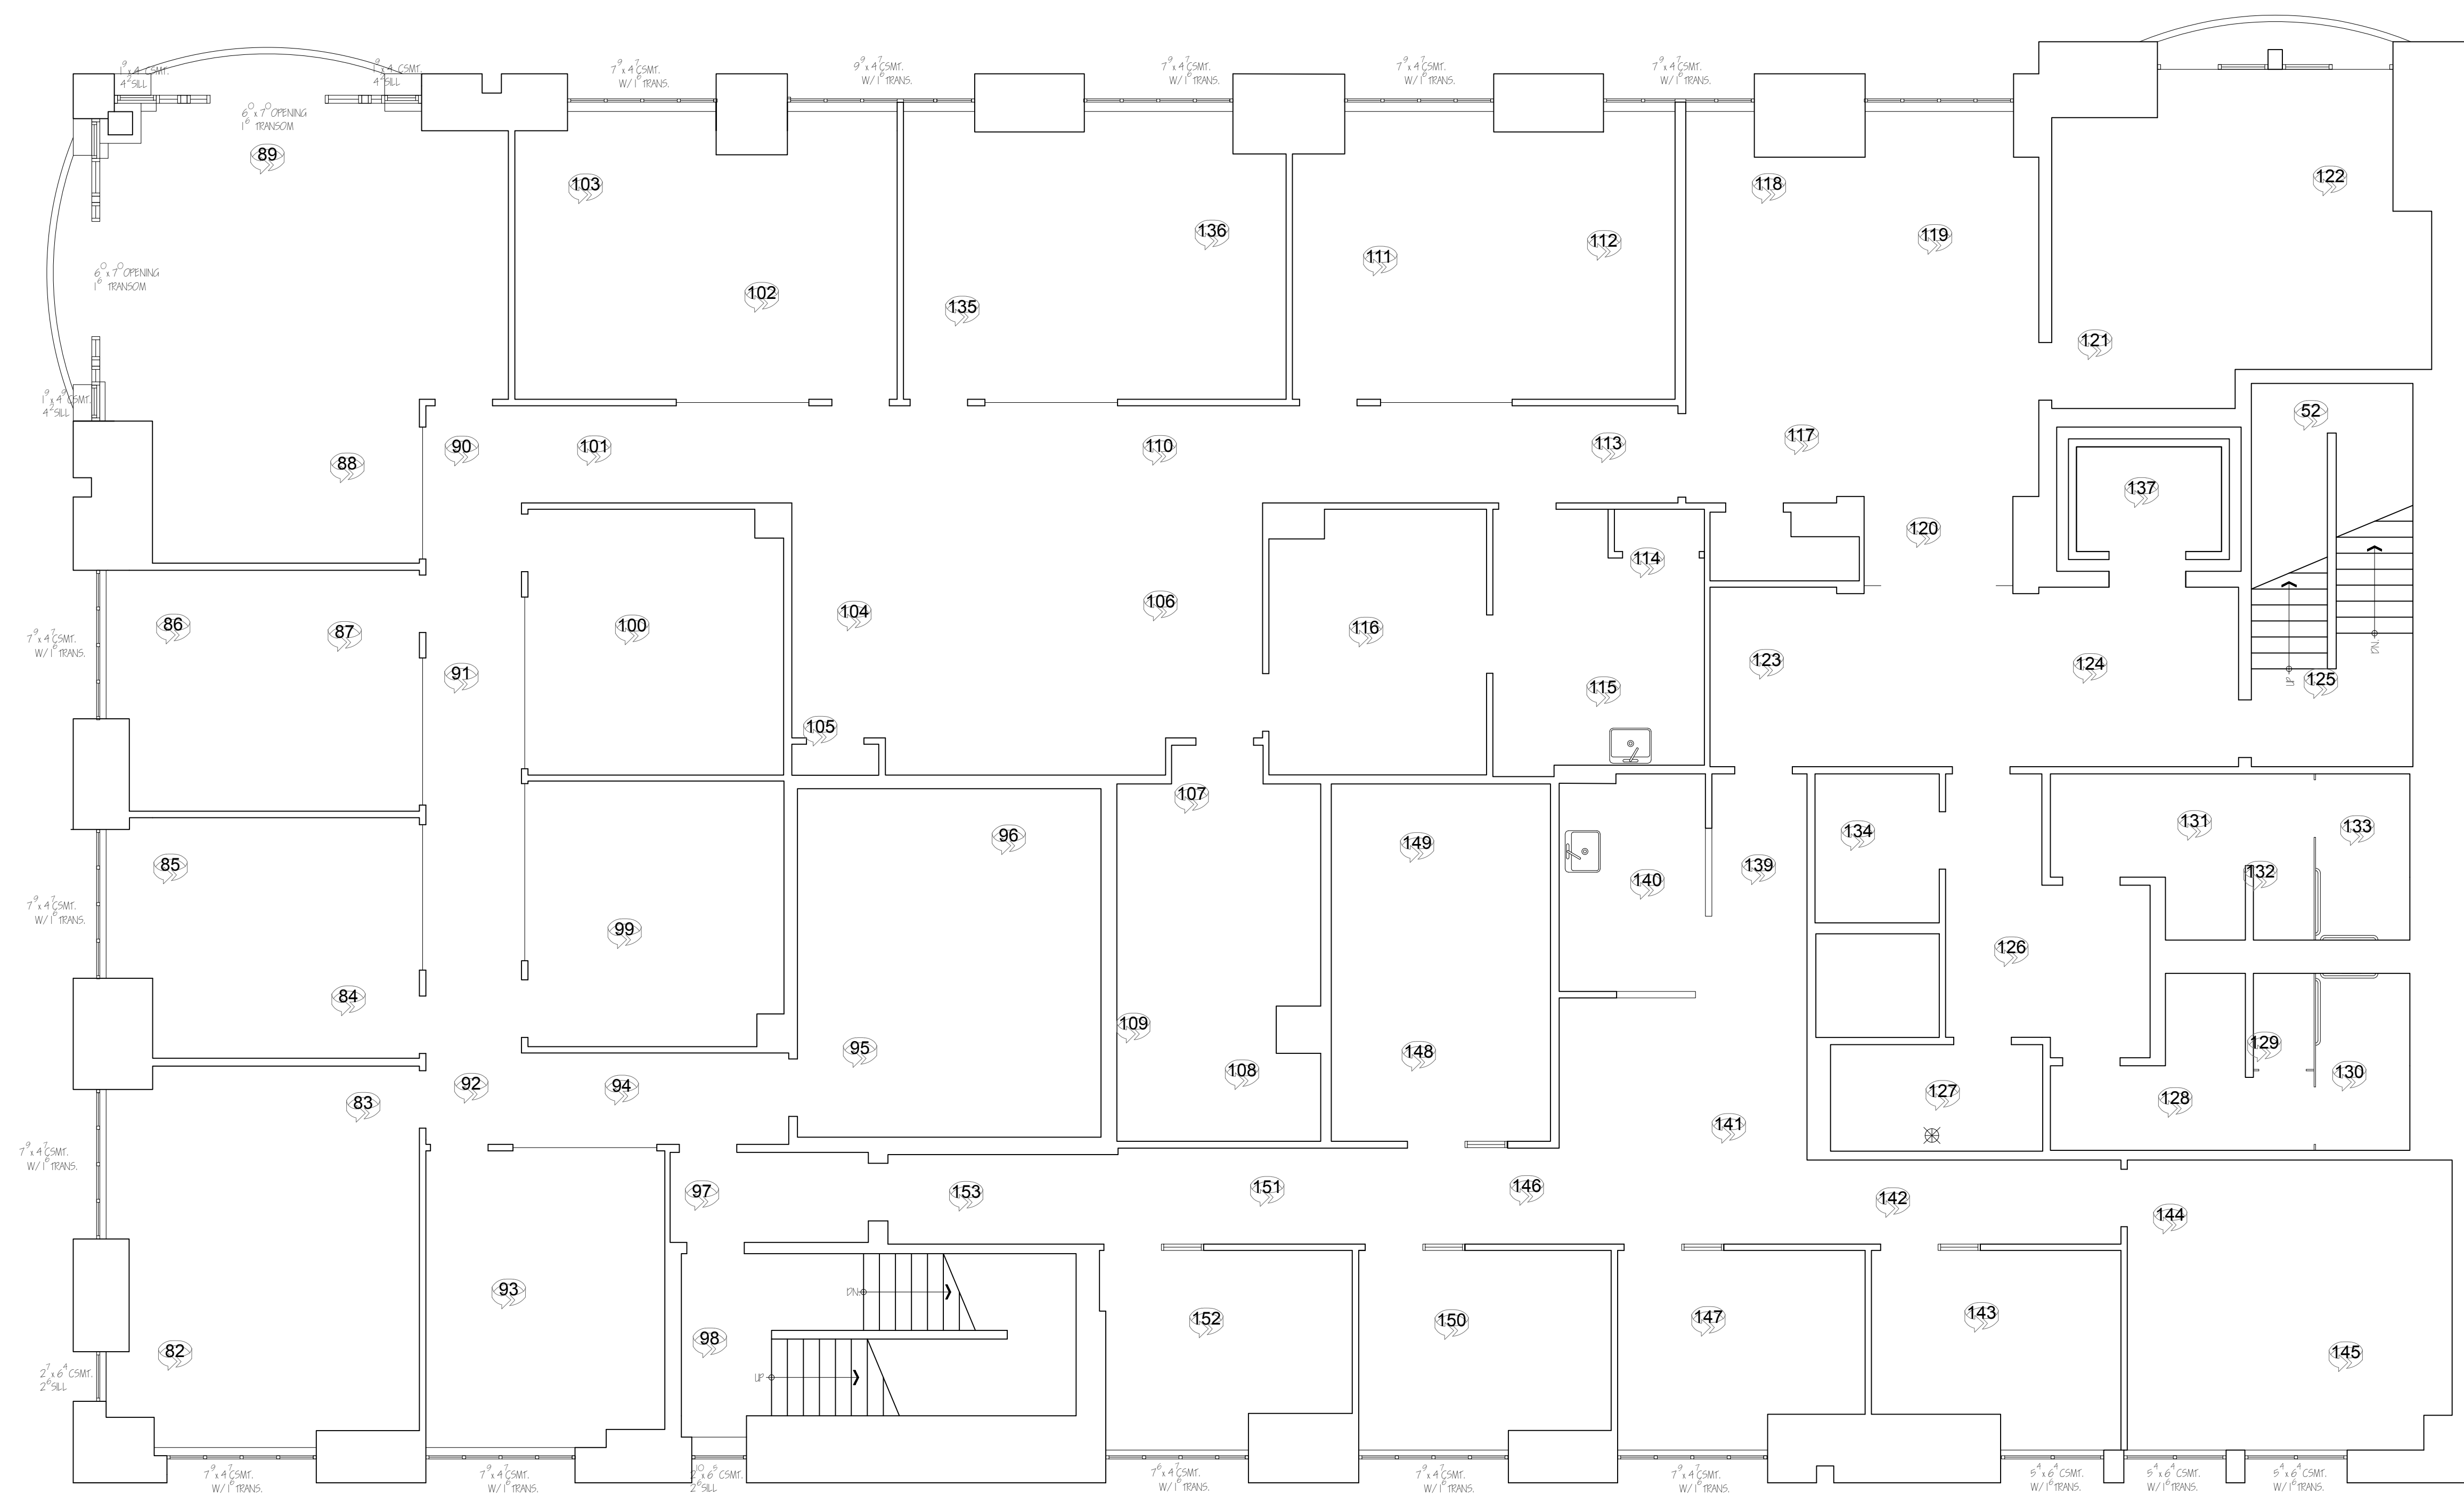
01	100% SUBMISSION	SEE COVER SHEET
NO.	ISSUES REVISIONS	DATE
		SHEET TITLE
HL	PROJECT MANAGER	
HL	PROJECT DIRECTOR	
012317-1	PROJECT NUMBER	
3/16"=1'-0"		SCALE
CL	DRAWN BY	
		SHEET NUMBER
AB-4		



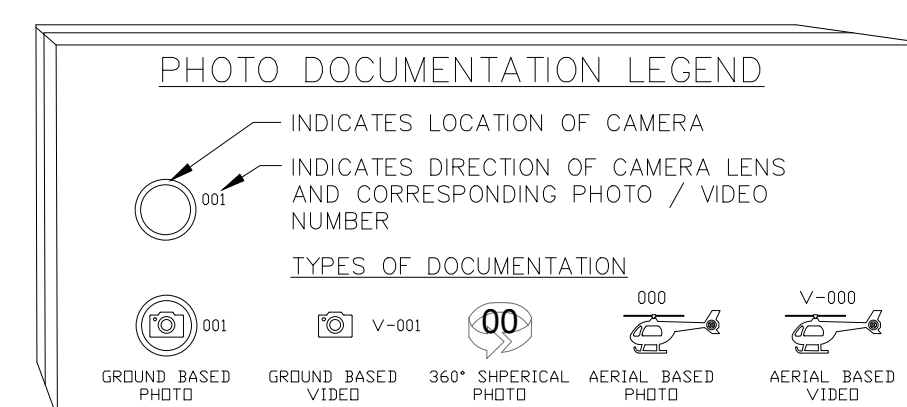
© 2017 AEC CONSULTANTS INC

ARCHITECTURAL AS BUILT

Palo Alto, CA 94301



SECOND FLOOR PLAN



01	100% SUBMISSION	SEE COVER SHEET
NO.	ISSUES REVISIONS	DATE
		SHEET TITLE
HL		PROJECT MANAGER
HL		PROJECT DIRECTOR
012317-1		PROJECT NUMBER
3/16"=1'-0"		SCALE
CL		DRAWN BY
		SHEET NUMBER

AB-5

Palo Alto, CA 94301

