

# AS-BUILT DOCUMENTATION


## SAN ANTONIO, TEXAS 78212



**100% SUBMITTAL**

### DRAWING INDEX

- C-1 COVER SHEET | DRAWING INDEX
- SL SYMBOLS LEGEND
- AB-1 FLOOR PLANS

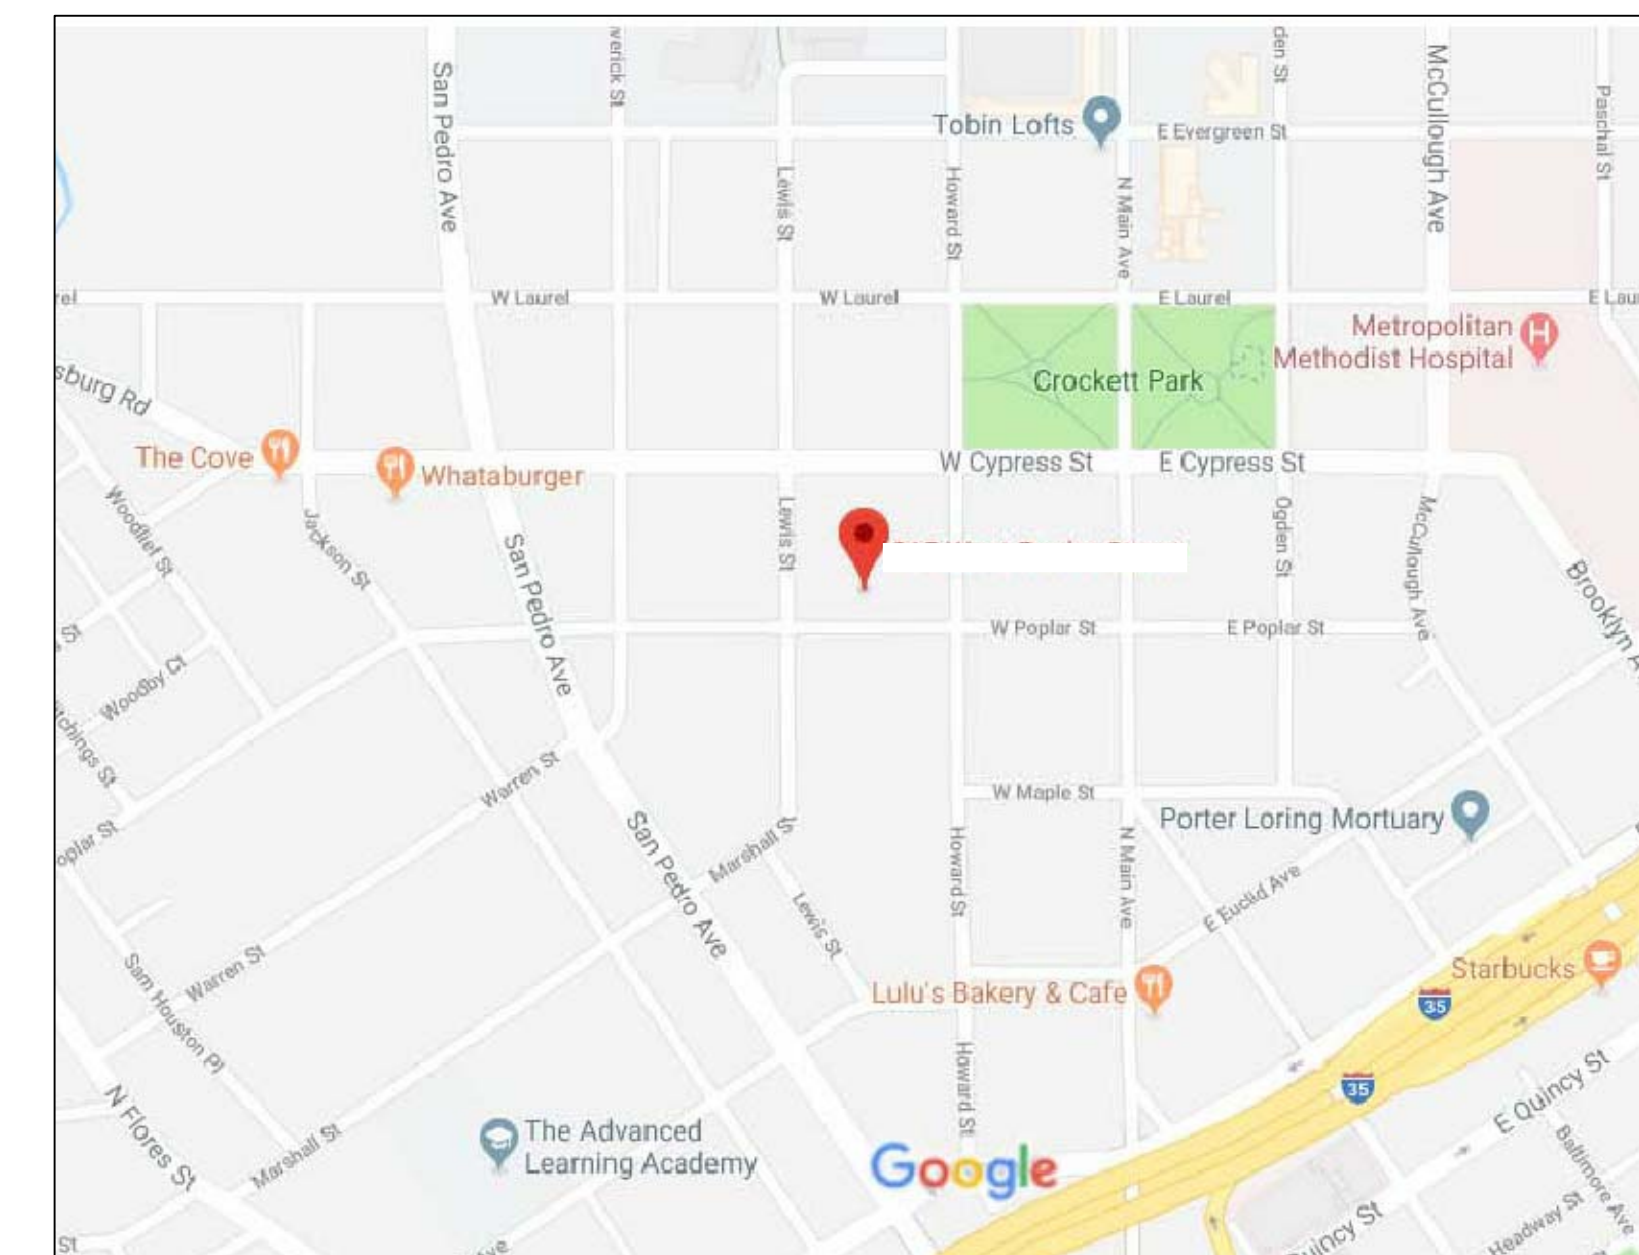

VICINITY MAP  
NTS

AREA DATA	
FIRST FLOOR LIVING	1,304 S.F.
ATTIC AREA	380 S.F.
GRAND TOTAL	1,684 S.F.

**AS BUILT**  
PROFESSIONALS  
www.asbuiltprofessionals.com

A DIVISION OF:

**AEC**  
CONSULTANTS INC

844.272.8458  
844 AS BUILT

© 2018 AEC CONSULTANTS INC

**ARCHITECTURAL AS BUILT**

**SAN ANTONIO, TX 78212**

O1	100% SUBMISSION	SEE COVER SHEET
NO.	ISSUES   REVISIONS	DATE
		SHEET TITLE

**COVER SHEET**

HL	PROJECT MANAGER
HL	PROJECT DIRECTOR
012317-1	PROJECT NUMBER
	SCALE
CL	DRAWN BY
	SHEET NUMBER

**C-1**

# SYMBOLS LEGEND

## RCP

	EXHAUST VENT		TRACK LIGHT OR VANITY LIGHT
	CEILING MOUNTED LIGHT FIXTURE		WALL-MOUNTED LIGHT FIXTURE
	CEILING MOUNTED DIRECTIONAL LIGHT		EMERGENCY EXIT SIGN
	RECESSED CAN LIGHT		EMERGENCY EXIT LIGHT
	EYEBALL OR SMALL CAN LIGHT		EMERGENCY EXIT LIGHT W/ SIGN
	PENDANT LIGHT		LIGHTED STAIR SIGN
	INDIVIDUAL FLUOR. LAY-IN FIXTURE 4 BULB		FLOOD LIGHT
	INDIVIDUAL FLUOR. HANGING FIXTURE 2 BULB		PHOTO CELL
	INDIVIDUAL FLUOR. FLUSH MOUNT FIXTURE 4 BULB		CEILING FAN
	CAMERA		CEILING FAN W/ LIGHT KIT
	MOTION DET.	<b>7-2-6</b>	CEILING HEIGHT AND TRIM 7'-2" ABOVE FLOOR BELOW WITH 6" CROWN MOULDING. NOTE: ALL CEILINGS NOT LABELED ARE PLASTER. CEILINGS SHOWN WITH A GRID ARE LAY IN ACOUSTICAL TILE..
	SUPPLY VENT		JUNCTION BOX
	RETURN VENT		
	SPEAKER		

## ELECTRIC

	DATA OUTLET
	TELEPHONE JACK
	ELECTRIC SWITCH
	CABLE TELEVISION OUTLET
	DUPLEX RECEPTACLE OUTLET
	SPECIAL PURPOSE CONNECTION OR OUTLET
	QUADRUPLEX RECEPTACLE OUTLET
	FLOOR DUPLEX RECEPTACLE OUTLET
	ELECTRIC PANEL
	ELECTRIC METER
	BUTTON SWITCH
	DISCONNECT SWITCH
	GROUND/FLOOR LIGHT
	KEY PAD

## FIRE PROTECTION


	FIRE EXTINGUISHER
	FIRE PULL
	FIRE ALARM (HORN/SRTOBE)
	SMOKE DETECTOR
	SMOKE ALARM SPEAKER
	SPRINKLER HEAD CEILING MOUNT
	SPRINKLER HEAD WALL MOUNT

## MEP


	THERMOSTAT
	FLOOR DRAIN
	VALVE
	HOSE BIB
	WATER SUPPLY
	SUSPENDED GAS HEATER

## MISC

	BOLLARD
	11-4-11/16 SPOT ELEVATION

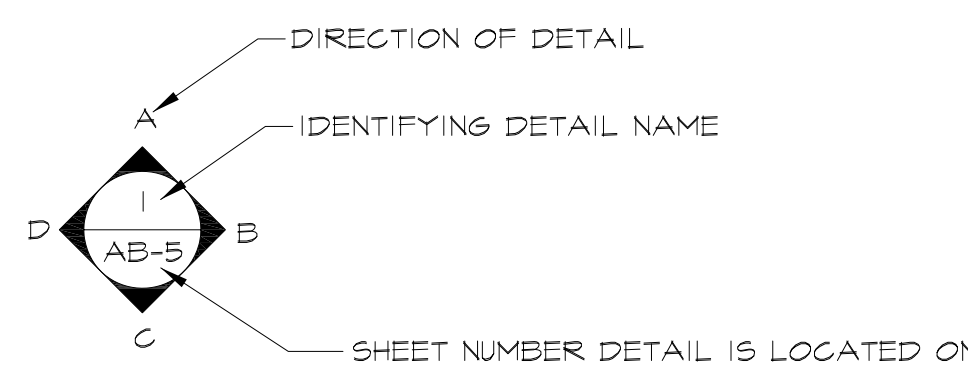

### INTERIOR ELEVATIONS

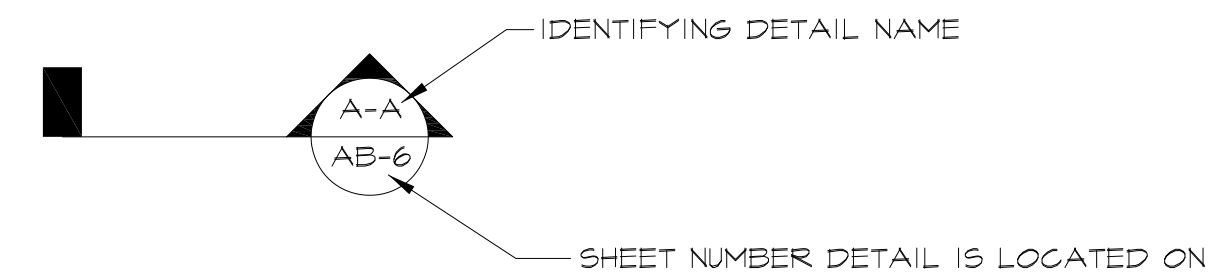

### BUILDING SECTION

#### PHOTO DOCUMENTATION LEGEND

INDICATES LOCATION OF CAMERA

INDICATES DIRECTION OF CAMERA LENS AND CORRESPONDING PHOTO / VIDEO NUMBER

TYPES OF DOCUMENTATION

	GROUND BASED PHOTO		GROUND BASED VIDEO		360° SPHERICAL PHOTO		AERIAL BASED PHOTO		AERIAL BASED VIDEO
--	--------------------	--	--------------------	--	----------------------	--	--------------------	--	--------------------


**ARCHITECTURAL AS BUILT**

**SAN ANTONIO, TX 78212**

01	100% SUBMISSION	SEE COVER SHEET
NO.	ISSUES   REVISIONS	DATE
SHEET TITLE		
HL	PROJECT MANAGER	
HL	PROJECT DIRECTOR	
012317-1	PROJECT NUMBER	
NOT TO SCALE		
CL	SCALE	
DRAWN BY		
SHEET NUMBER		


**ARCHITECTURAL AS BUILT**

**SAN ANTONIO, TX 78212**

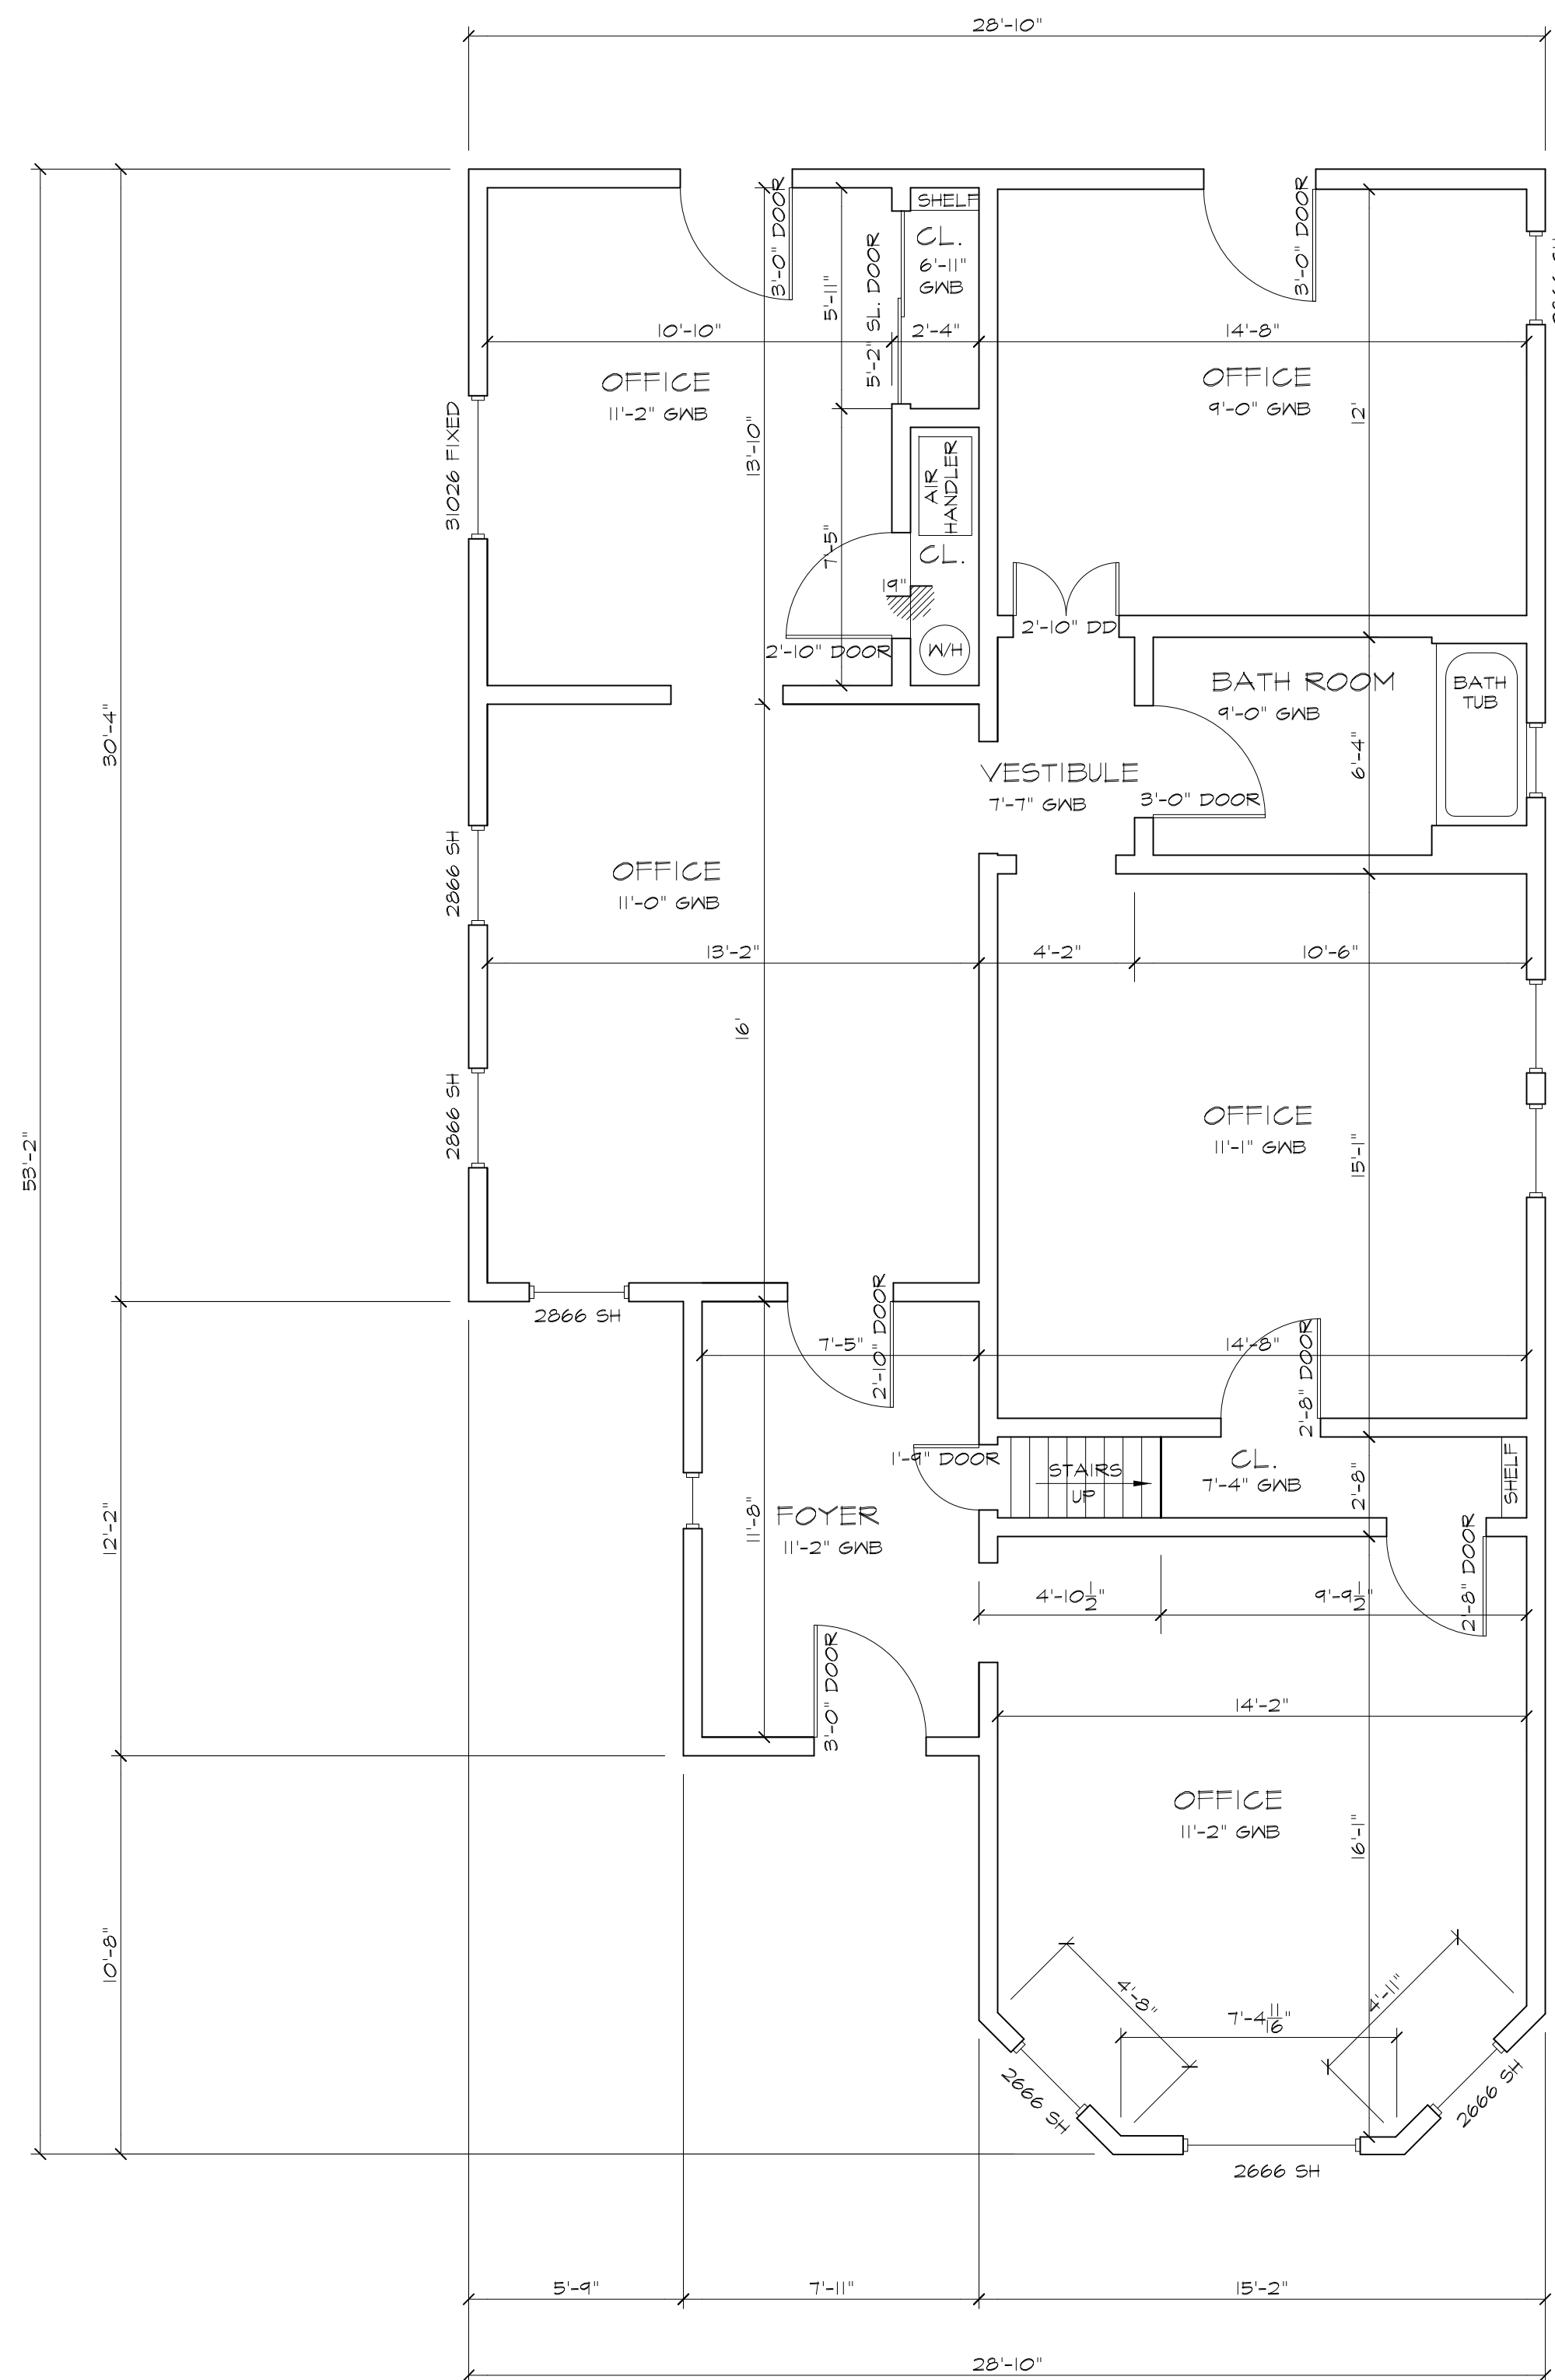

FIRST FLOOR PLAN

AREA DATA	
FIRST FLOOR LIVING	1,304 S.F.
ATTIC AREA	380 S.F.
GRAND TOTAL	1,684 S.F.

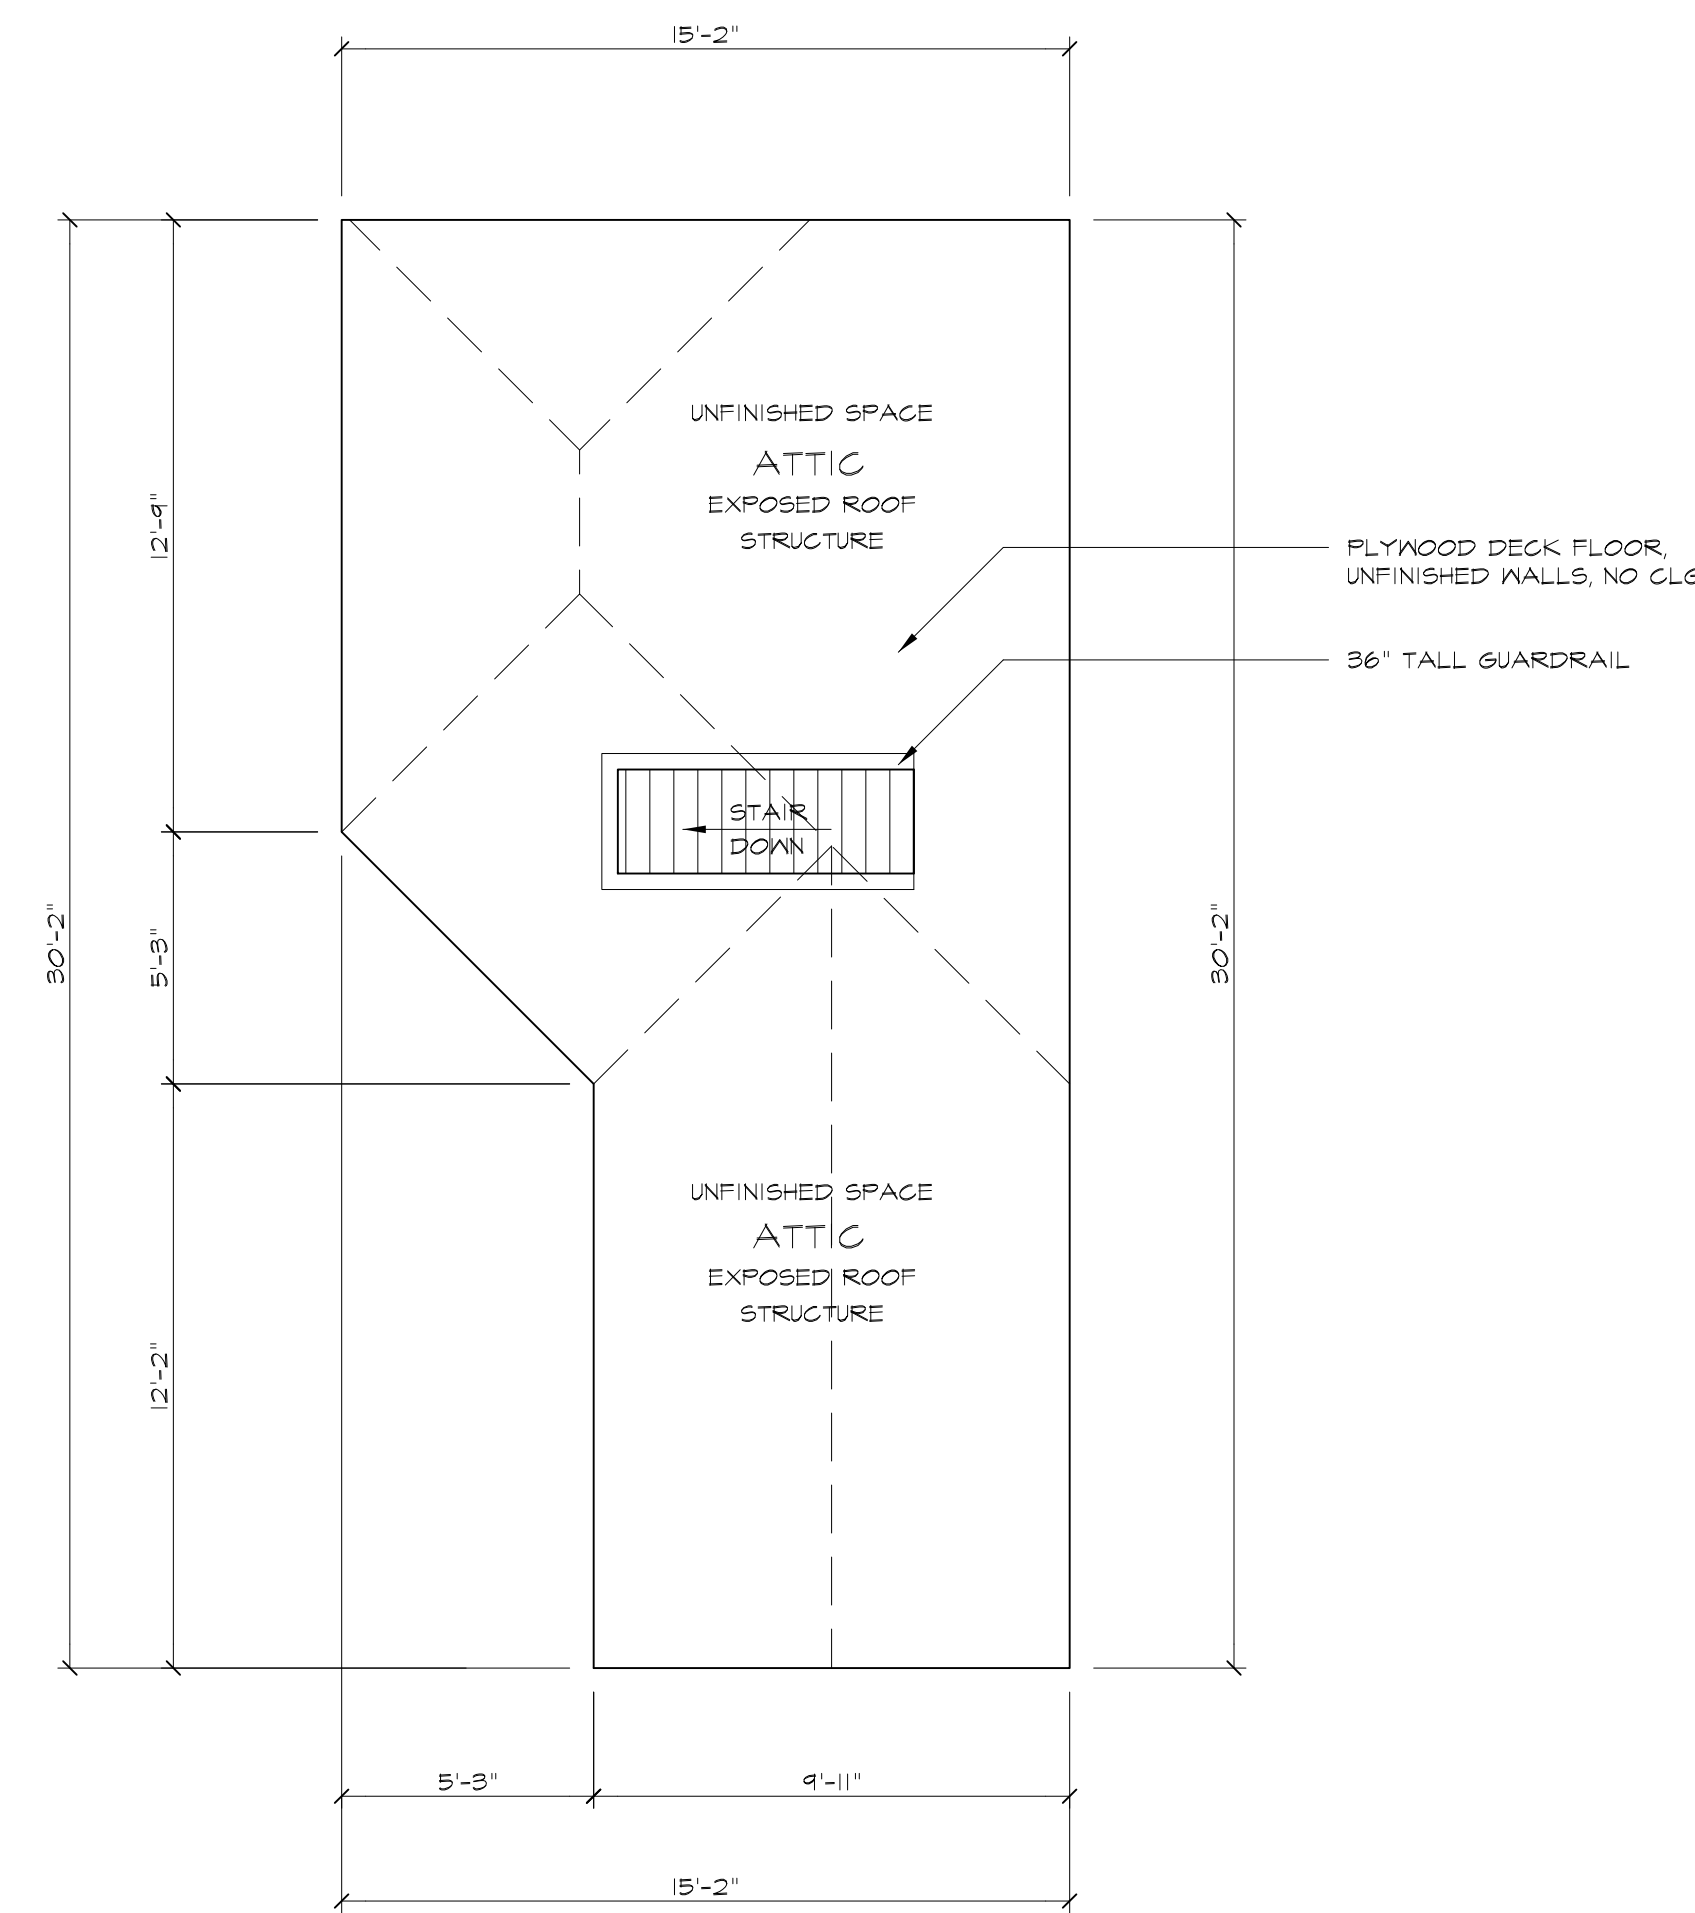

ATTIC FLOOR PLAN

01	100% SUBMISSION	SEE COVER SHEET
NO.	ISSUES   REVISIONS	DATE
SHEET TITLE		

HL	PROJECT MANAGER
HL	PROJECT DIRECTOR
012317-1	PROJECT NUMBER
1/4"=1'-0"	SCALE
CL	DRAWN BY
	SHEET NUMBER

**AB-1**