

AS-BUILT DOCUMENTATION


Chadds Ford, PA 19317 Master Bedroom Plan



100% SUBMITTAL

DRAWING INDEX

- C-1 COVER SHEET | DRAWING INDEX
- SL SYMBOLS LEGEND
- AB-1 MASTER BEDROOM FLOOR PLAN
- AB-2 REFLECTED CEILING PLAN
- AB-3 INTERIOR ELEVATIONS

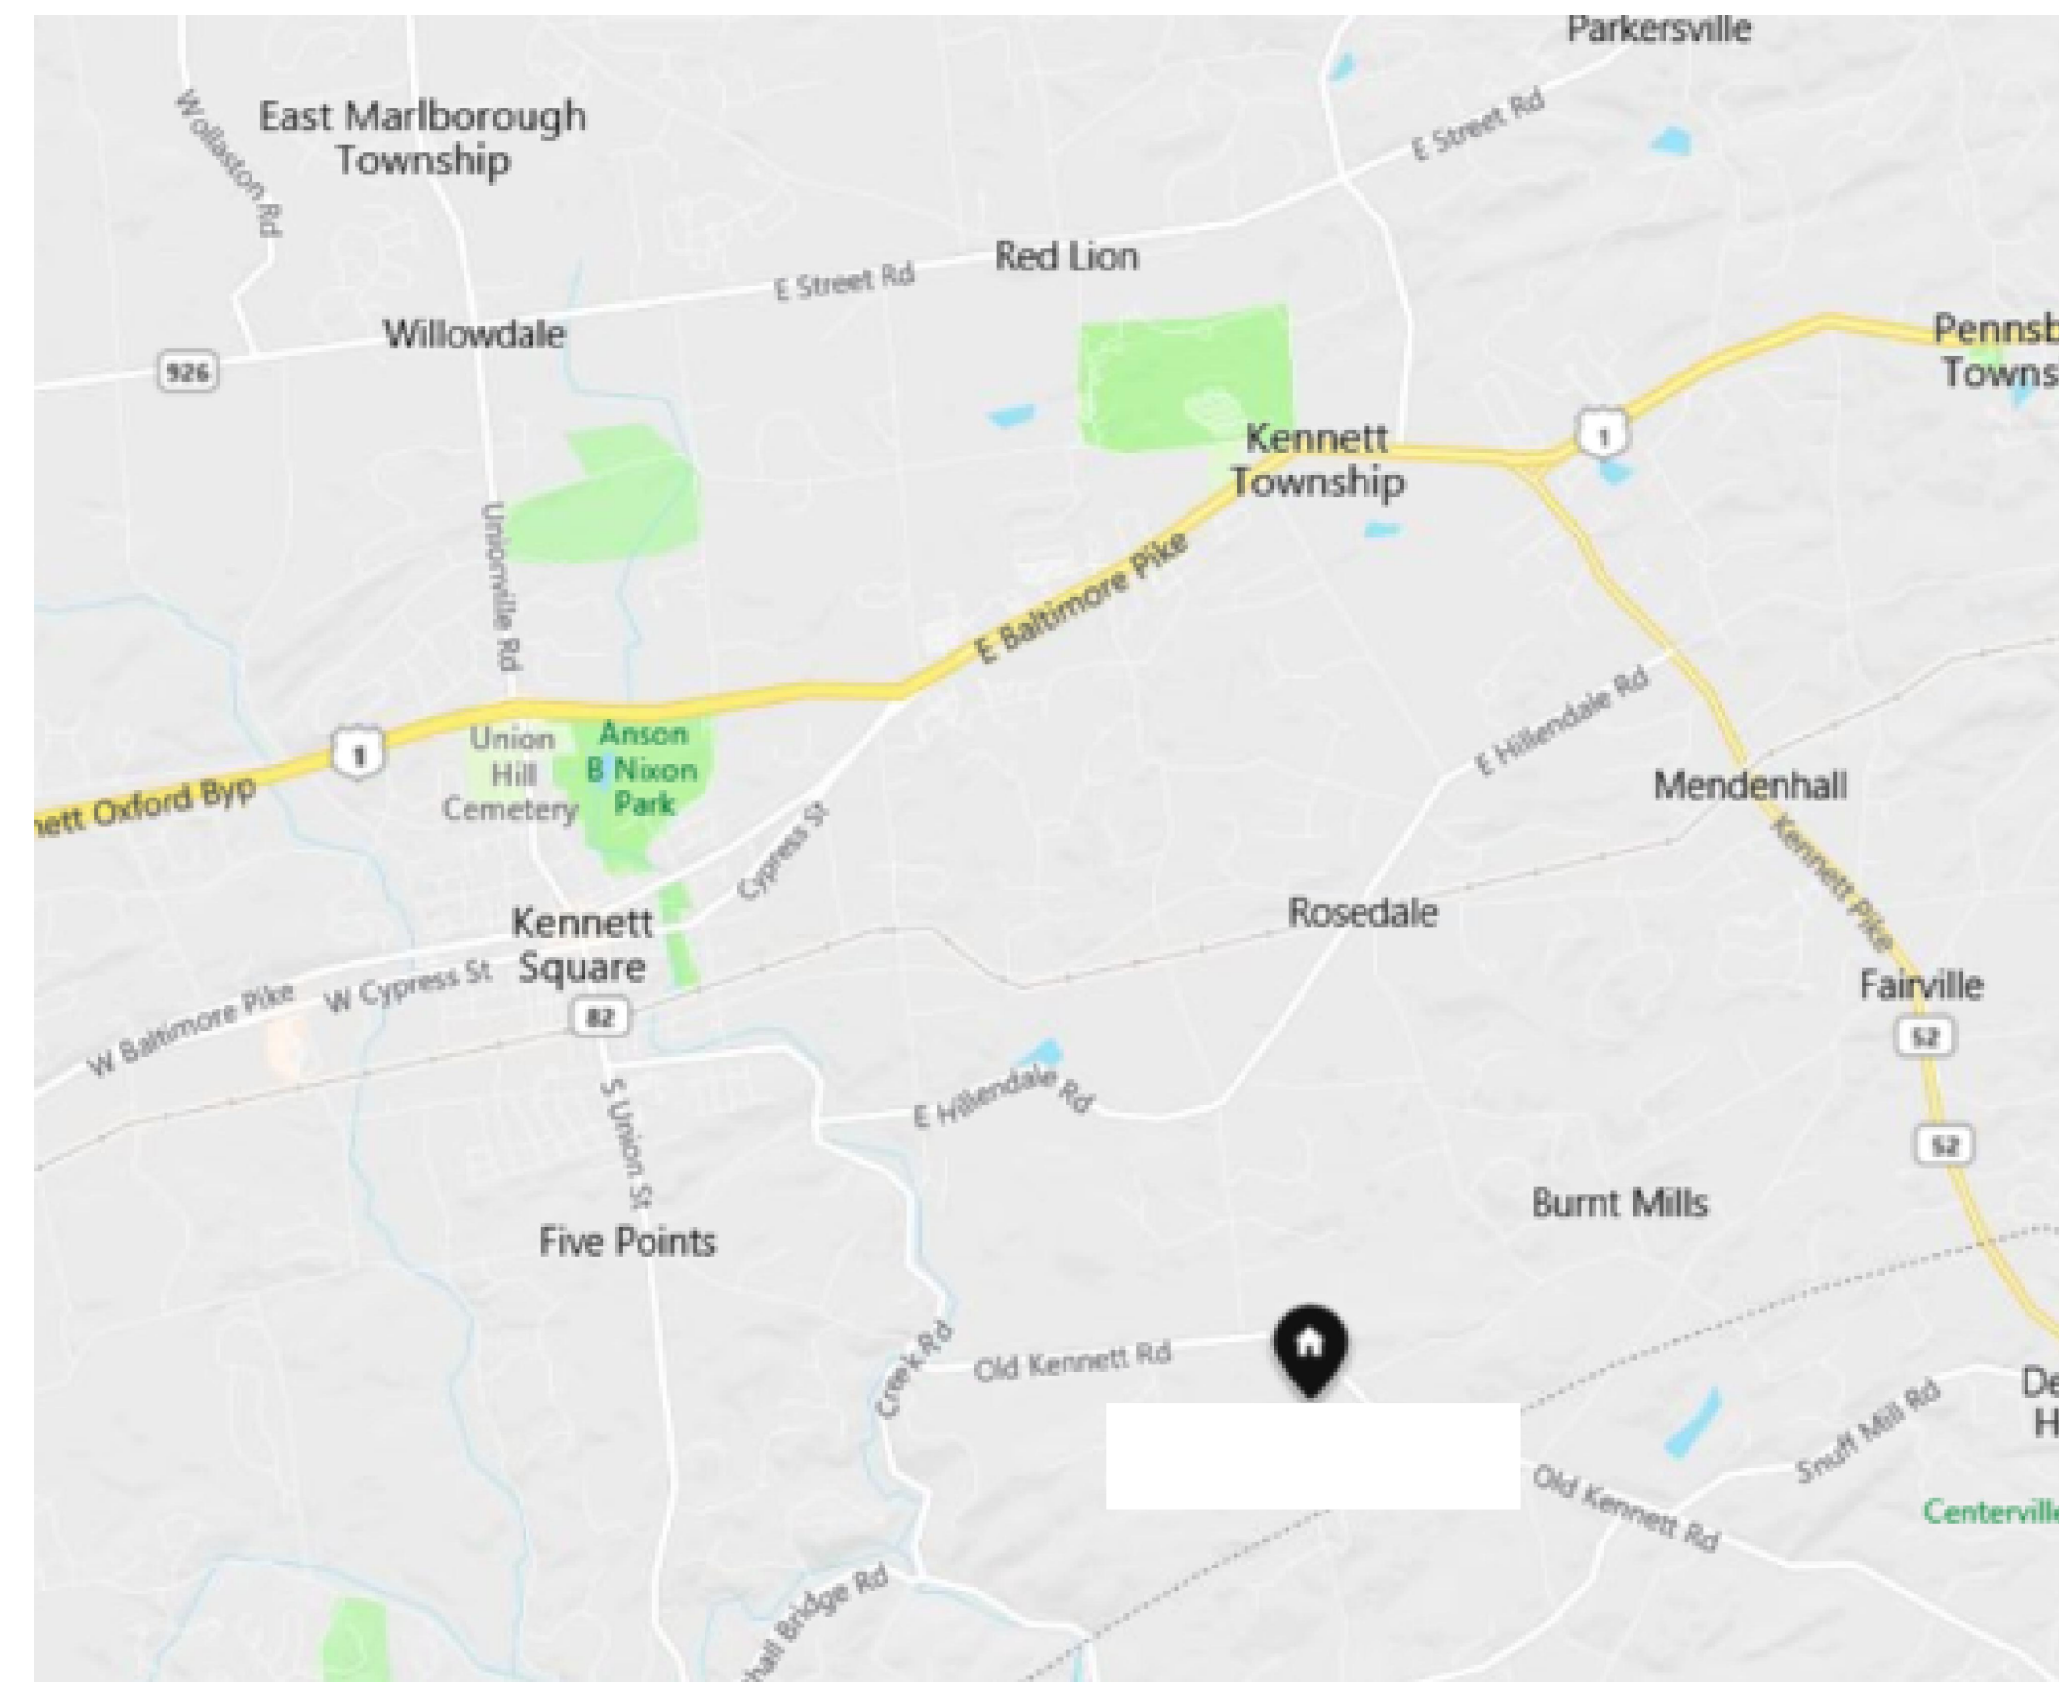

VICINITY MAP
NTS

AREA DATA	
MASTER BEDROOM	276 S.F. ±
PROJECT TOTAL	276 S.F. ±

AS BUILT
PROFESSIONALS
www.asbuiltprofessionals.com
A DIVISION OF:

AEC
CONSULTANTS INC
844.272.8458
844 A S BUILT

© 2019 AEC CONSULTANTS INC

ARCHITECTURAL AS BUILT


 
 
 

 


 


 


 

**Chadds Ford, PA 19317
Master Bedroom**

 

 
 
 

 
 

 
 

01	100% SUBMISSION	DATE
NO.	ISSUES REVISIONS	DATE
SHEET TITLE		
COVER SHEET		
HL	PROJECT MANAGER	
HL	PROJECT DIRECTOR	
012317-1	PROJECT NUMBER	
	SCALE	
CL	DRAWN BY	
	SHEET NUMBER	

C-1



 

 





 

 

SYMBOLS LEGEND

RCP




 
 
 
 
-  EXHAUST VENT
-  CEILING MOUNTED LIGHT FIXTURE
-  CEILING MOUNTED DIRECTIONAL LIGHT
-  RECESSED CAN LIGHT
-  EYEBALL OR SMALL CAN LIGHT
-  PENDANT LIGHT
-  INDIVIDUAL FLUOR. LAY-IN FIXTURE 4 BULB
-  INDIVIDUAL FLUOR. HANGING FIXTURE 2 BULB
-  INDIVIDUAL FLUOR. FLUSH MOUNT FIXTURE 4 BULB
-  CAMERA
-  MOTION DET.
-  SUPPLY VENT
-  SUPPLY VENT
-  RETURN VENT
-  RETURN VENT
-  SPEAKER

-  TRACK LIGHT OR VANITY LIGHT
-  WALL-MOUNTED LIGHT FIXTURE
-  EMERGENCY EXIT SIGN
-  EMERGENCY EXIT LIGHT
-  EMERGENCY EXIT LIGHT W/ SIGN
-  LIGHTED STAIR SIGN
-  FLOOD LIGHT
-  PHOTO CELL
-  CEILING FAN
-  CEILING FAN W/ LIGHT KIT
-  **7-2-6** CEILING HEIGHT AND TRIM 7'-2" ABOVE FLOOR BELOW WITH 6" CROWN MOULDING. NOTE: ALL CEILINGS NOT LABELED ARE PLASTER. CEILINGS SHOWN WITH A GRID ARE LAY IN ACOUSTICAL TILE..
-  JUNCTION BOX





 

ELECTRIC

-  DATA OUTLET
-  TELEPHONE JACK
-  ELECTRIC SWITCH
-  CABLE TELEVISION OUTLET
-  DUPLEX RECEPTACLE OUTLET
-  SPECIAL PURPOSE CONNECTION OR OUTLET
-  QUADRUPLEX RECEPTACLE OUTLET
-  FLOOR DUPLEX RECEPTACLE OUTLET
-  ELECTRIC PANEL
-  ELECTRIC METER
-  BUTTON SWITCH
-  DISCONNECT SWITCH
-  GROUND/FLOOR LIGHT
-  KEY PAD

FIRE PROTECTION

-  FIRE EXTINGUISHER
-  FIRE PULL
-  FIRE ALARM (HORN/SRTOBE)
-  SMOKE DETECTOR
-  SMOKE ALARM SPEAKER
-  SPRINKLER HEAD CEILING MOUNT
-  SPRINKLER HEAD WALL MOUNT

MEP

-  THERMOSTAT
-  FLOOR DRAIN
-  VALVE
-  HOSE BIB
-  WATER SUPPLY
-  SUSPENDED GAS HEATER

MISC

-  BOLLARD
-  1-4-11/16 SPOT ELEVATION

7-2-6 CEILING HEIGHT AND TRIM 7'-2" ABOVE FLOOR BELOW WITH 6" CROWN MOULDING. NOTE: ALL CEILINGS NOT LABELED ARE PLASTER. CEILINGS SHOWN WITH A GRID ARE LAY IN ACOUSTICAL TILE..




 





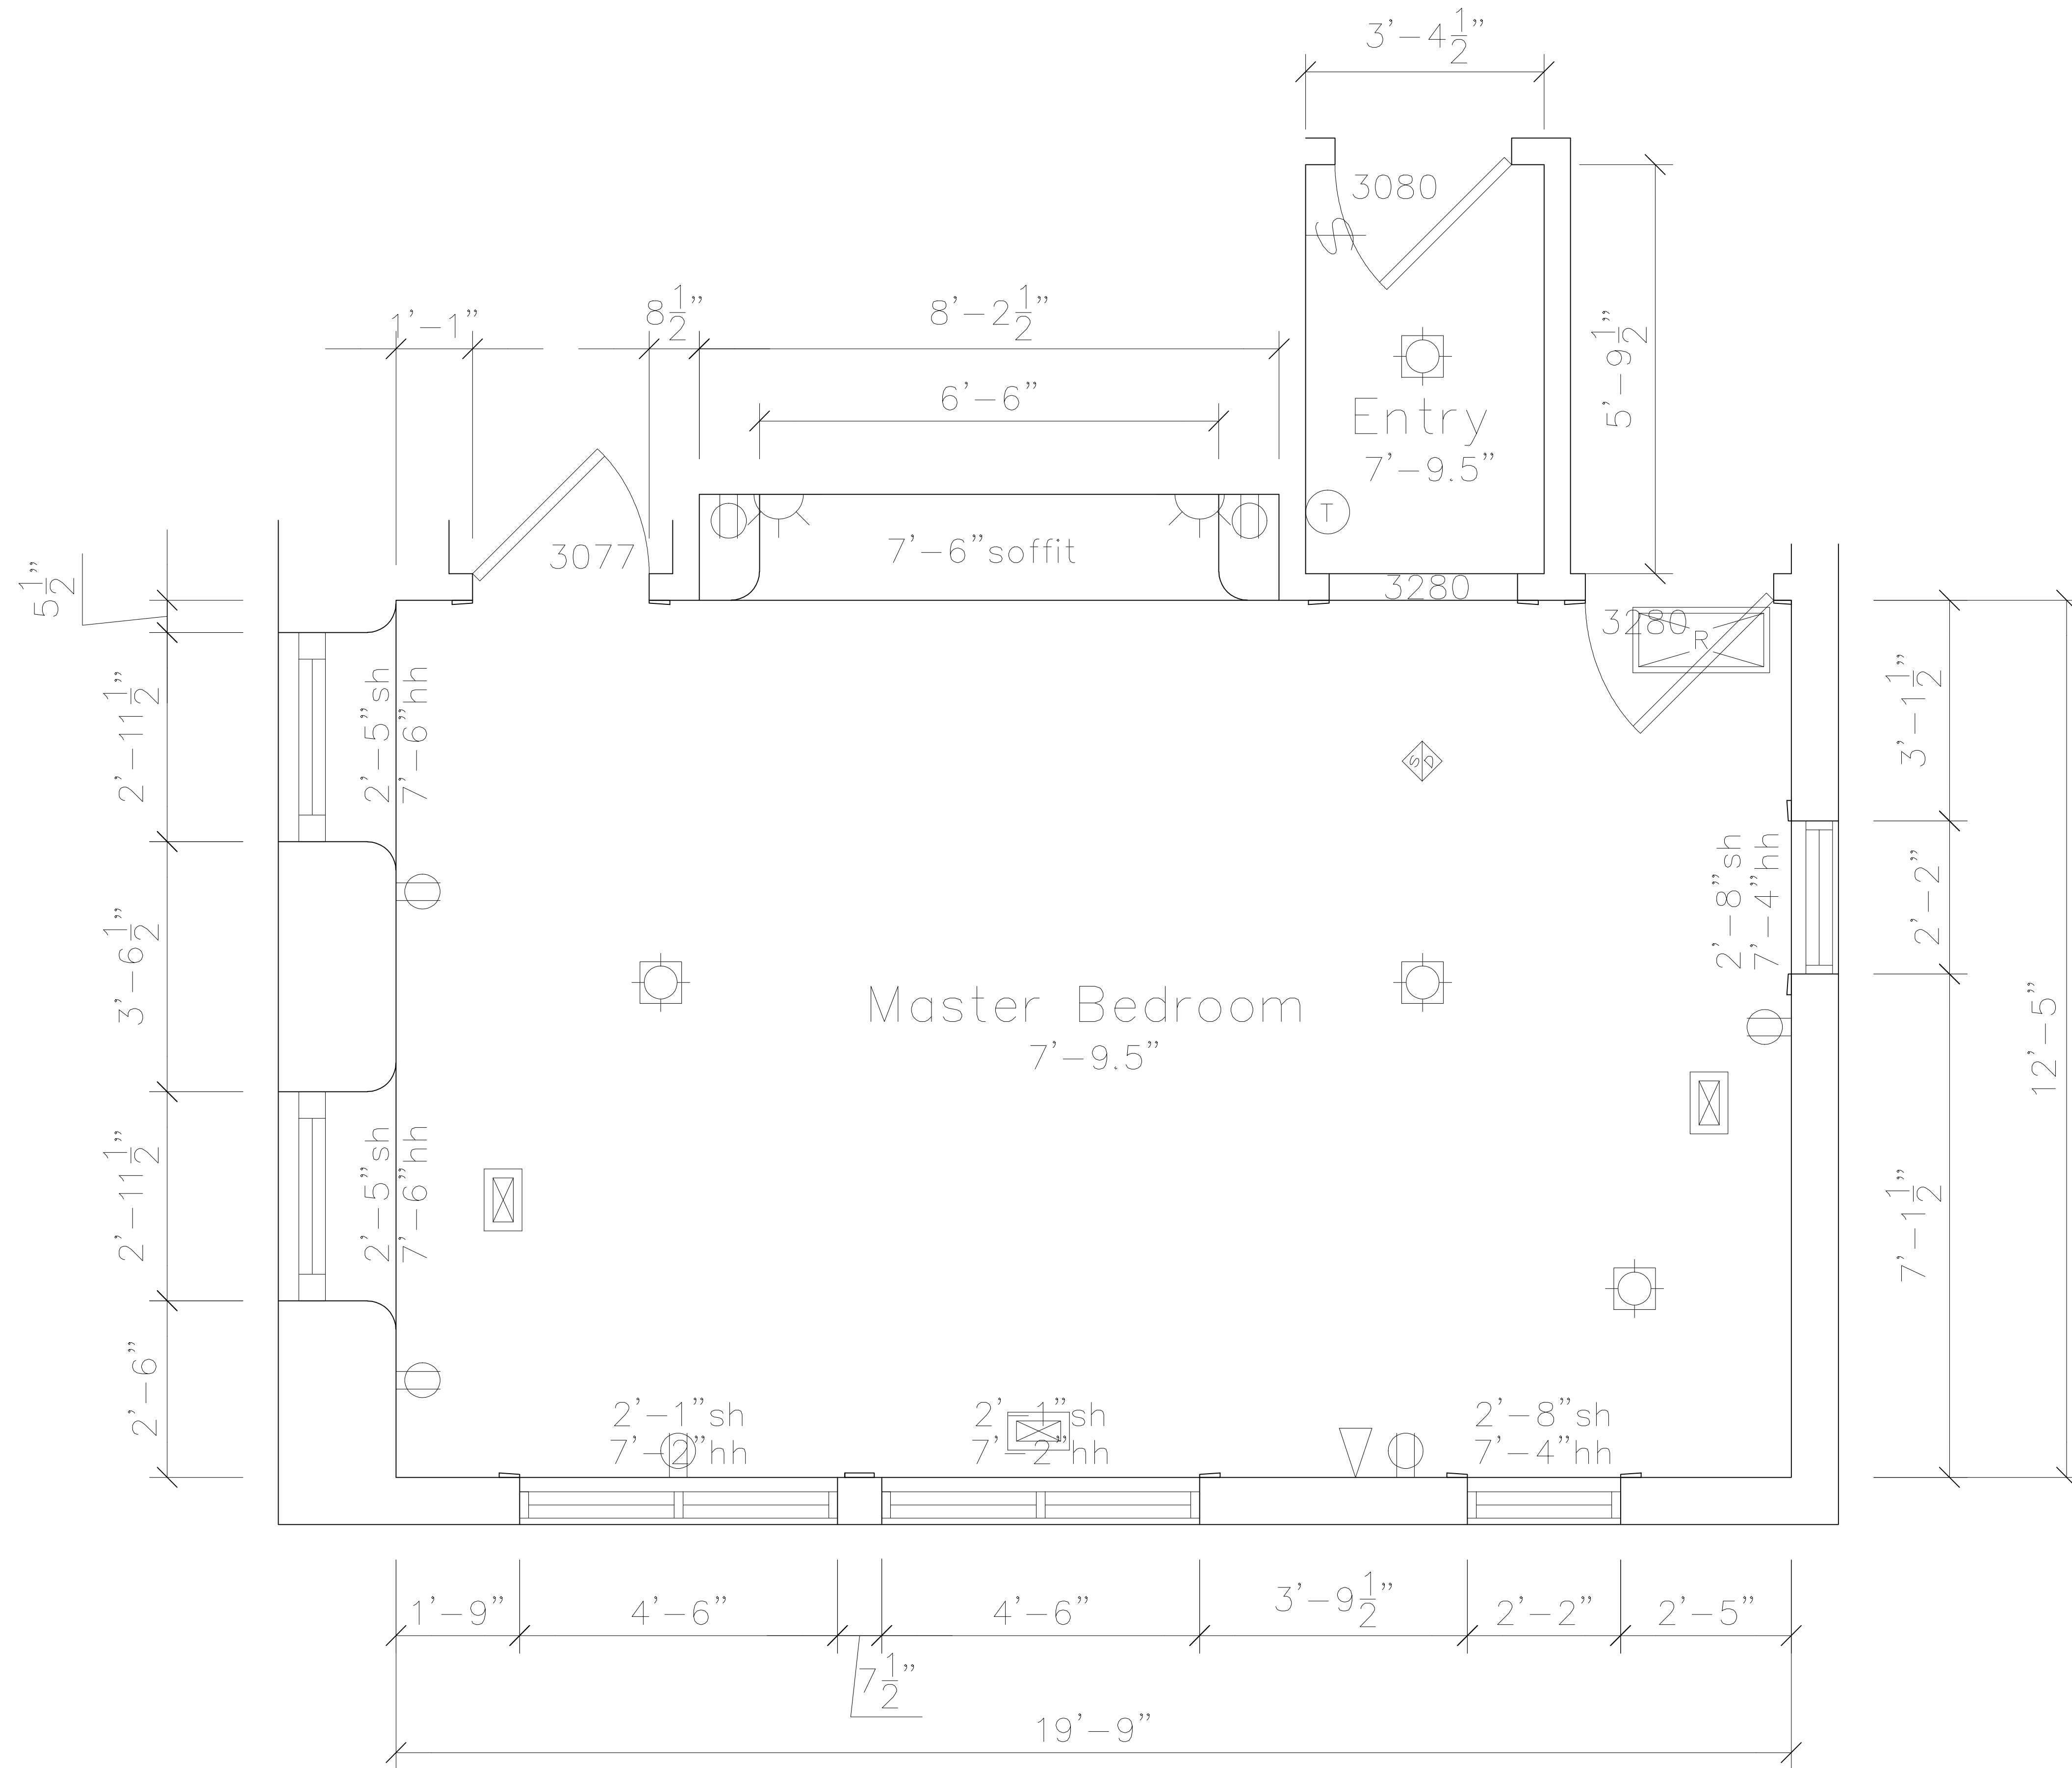


PHOTO DOCUMENTATION LEGEND

-  INDICATES LOCATION OF CAMERA
 -  INDICATES DIRECTION OF CAMERA LENS AND CORRESPONDING PHOTO / VIDEO NUMBER
- TYPES OF DOCUMENTATION
-  001 GROUND BASED PHOTO
 -  V-001 GROUND BASED VIDEO
 -  123 360° SPHERICAL PHOTO
 -  AERIAL BASED PHOTO
 -  AERIAL BASED VIDEO

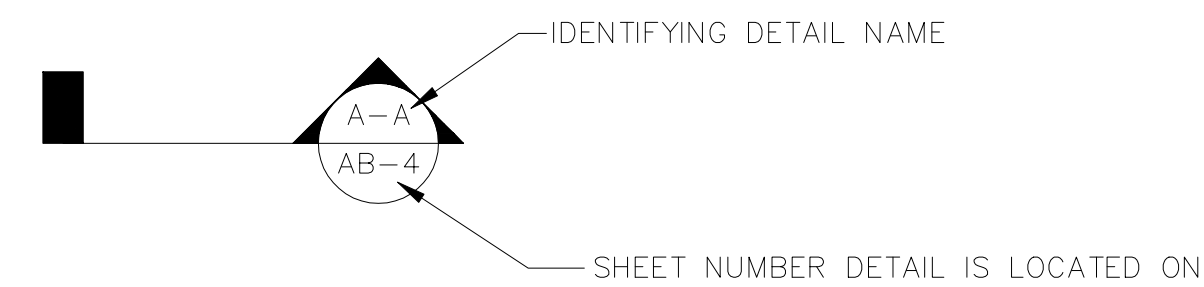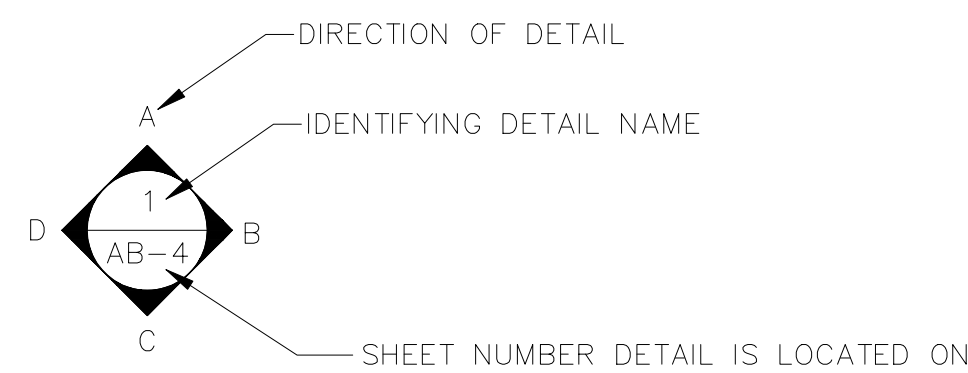ARCHITECTURAL AS BUILT
Chadds Ford, PA 19317
Master Bedroom

01	100% SUBMISSION	
NO.	ISSUES REVISIONS	DATE
SHEET TITLE		
HL		PROJECT MANAGER
HL		PROJECT DIRECTOR
012317-1		PROJECT NUMBER
NOT TO SCALE		SCALE
CL		DRAWN BY
SHEET NUMBER		




FULL FLOOR PLAN

ARCHITECTURAL AS BUILT

Chadds Ford, PA 19317 Master Bedroom

01	100% SUBMISSION	
NO.	ISSUES REVISIONS	DATE
		SHEET TITLE
HL		PROJECT MANAGER
HL		PROJECT DIRECTOR
012317-1		PROJECT NUMBER
3/4"=1'-0"		SCALE
CL		DRAWN BY
		SHEET NUMBER

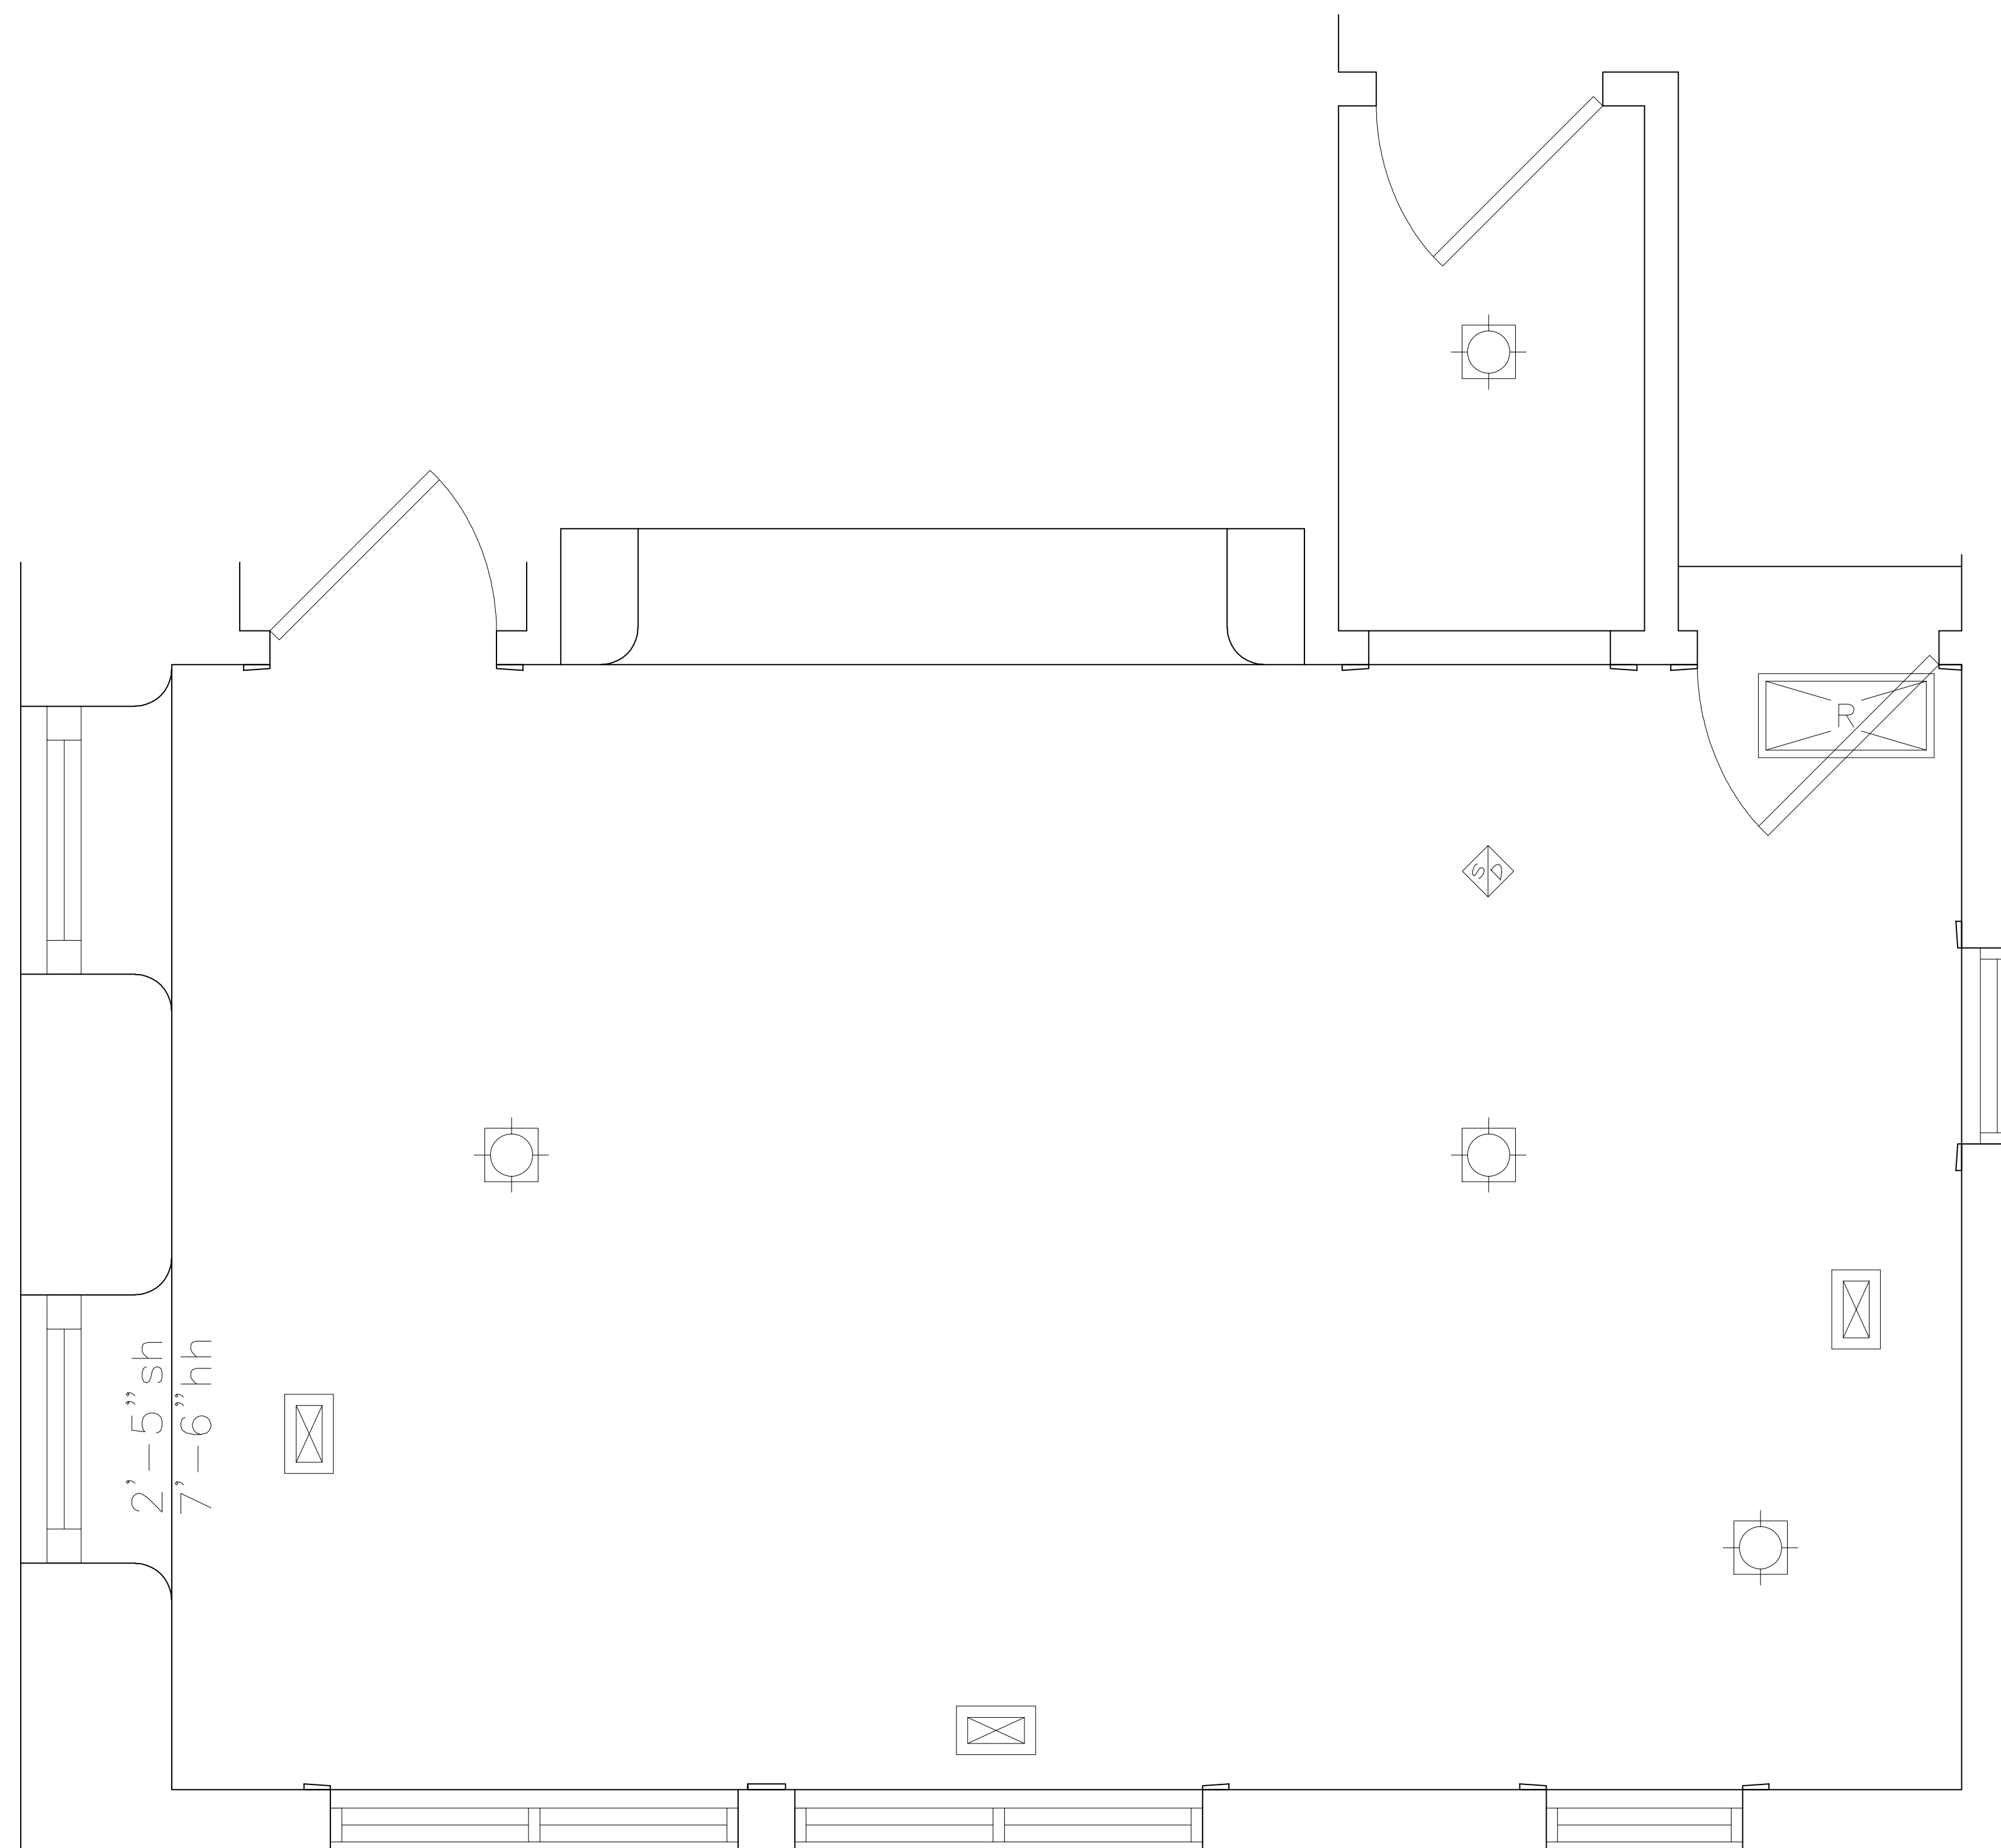

REFLECTED CEILING PLAN

7'-9.5" Ceiling Heights

ARCHITECTURAL AS BUILT

**Chadds Ford, PA 19317
Master Bedroom**

01 100% SUBMISSION

NO. ISSUES | REVISIONS DATE

SHEET TITLE

HL PROJECT MANAGER

HL PROJECT DIRECTOR


012317-1 PROJECT NUMBER

3/4"=1'-0" SCALE


CL DRAWN BY

SHEET NUMBER


AB-2

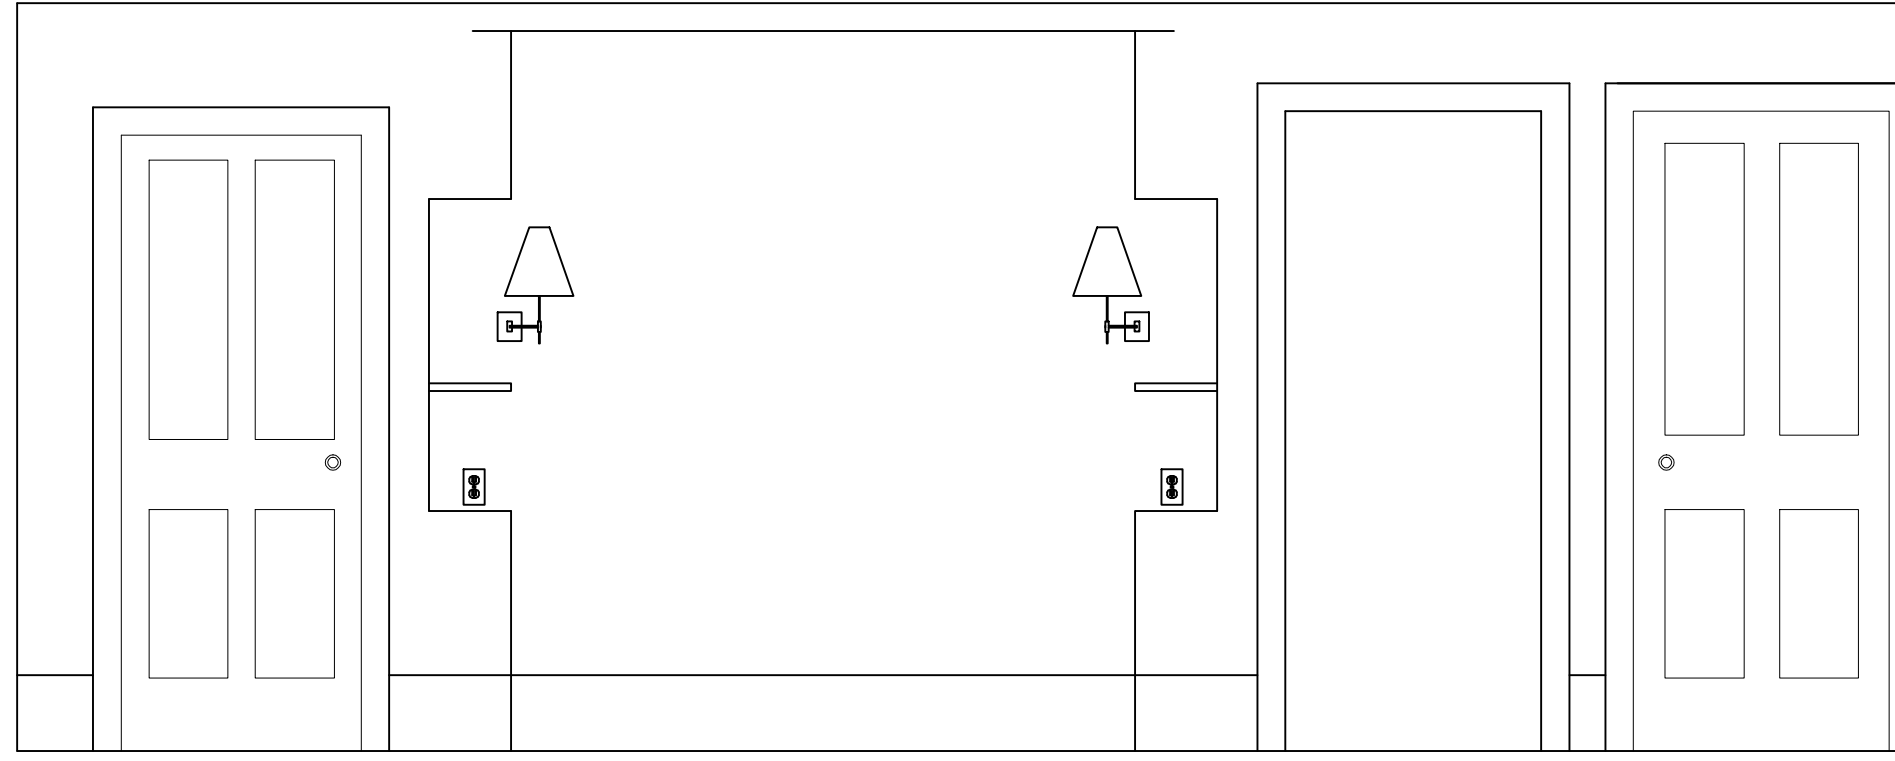


INTERIOR WALL "A"

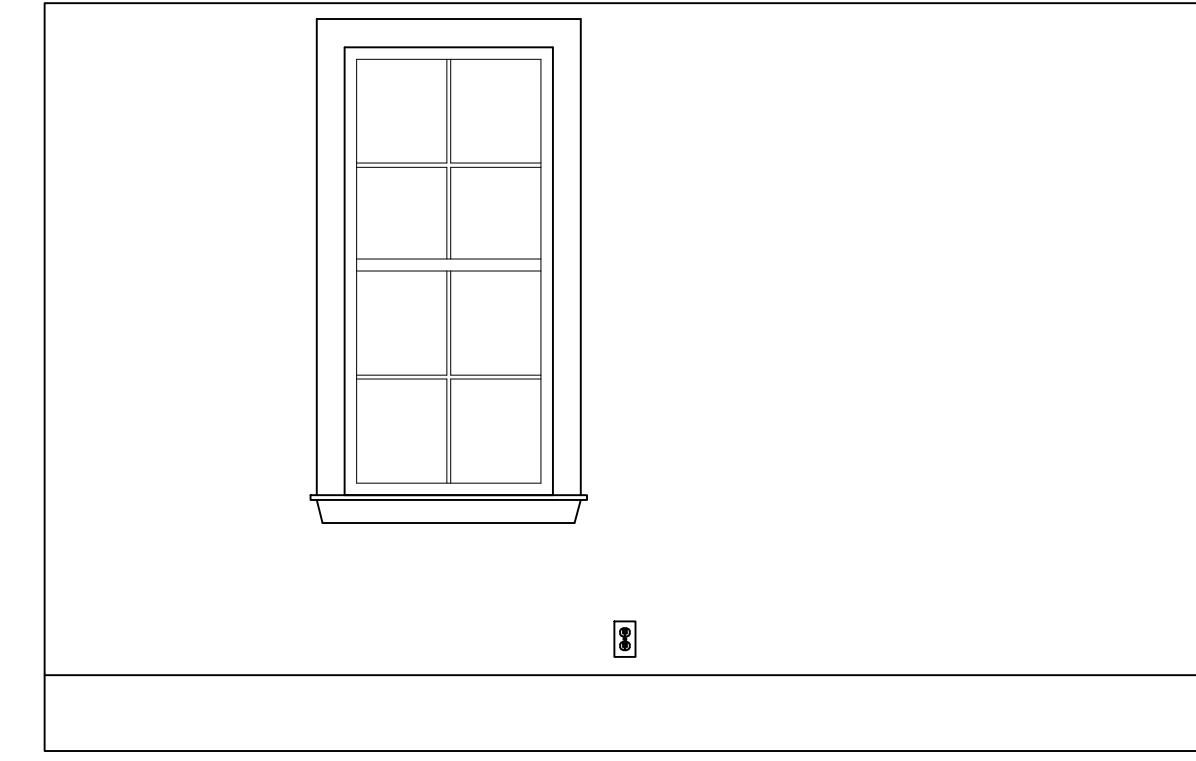

INTERIOR WALL "B"

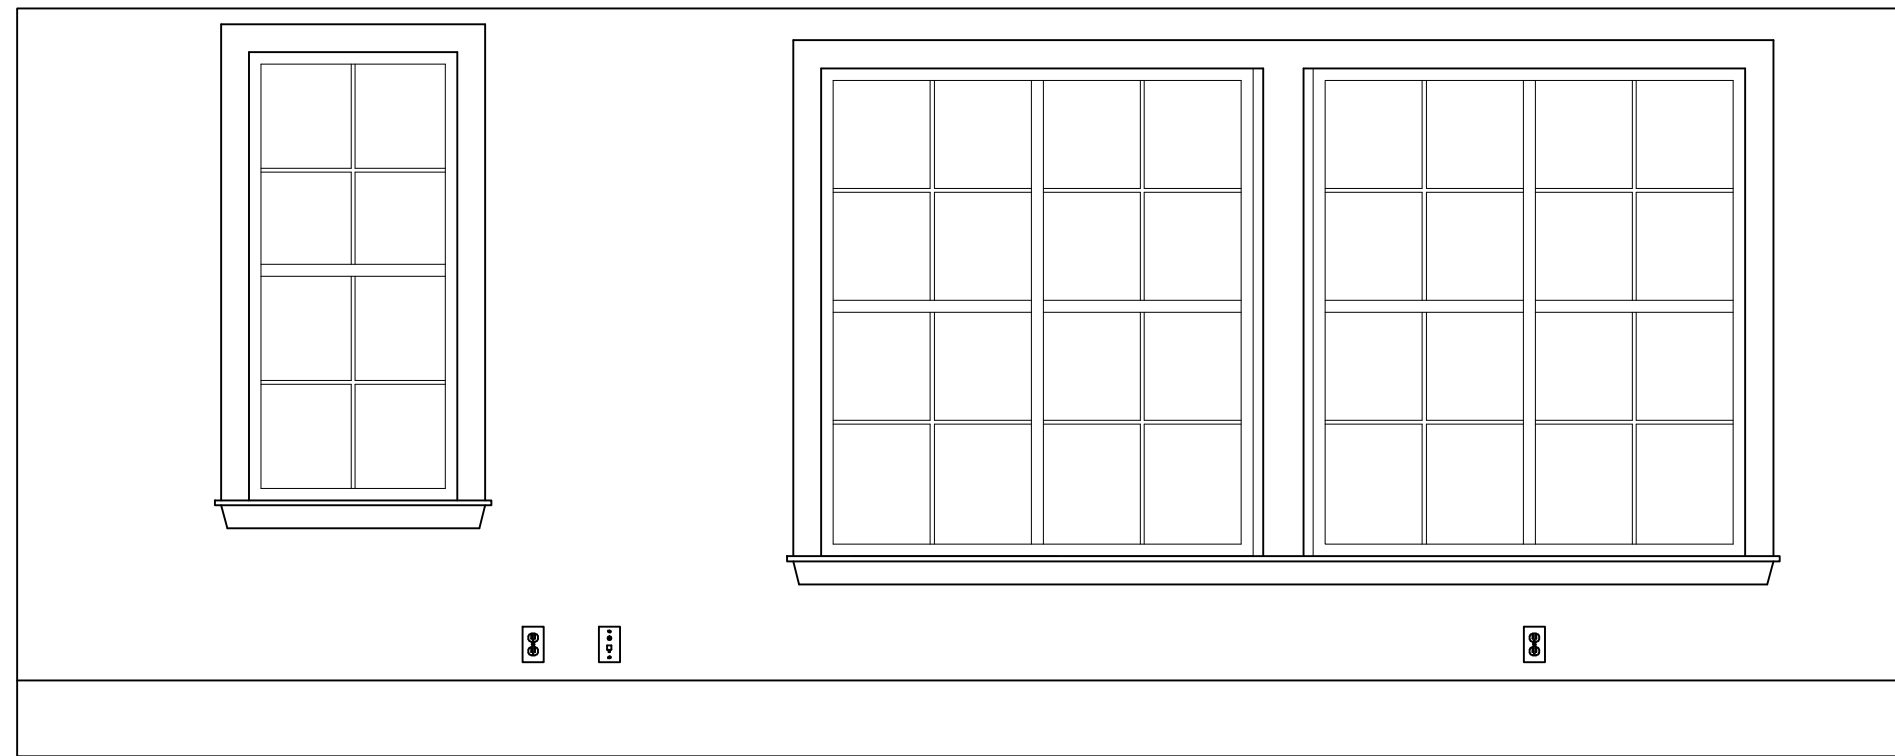

INTERIOR WALL "C"

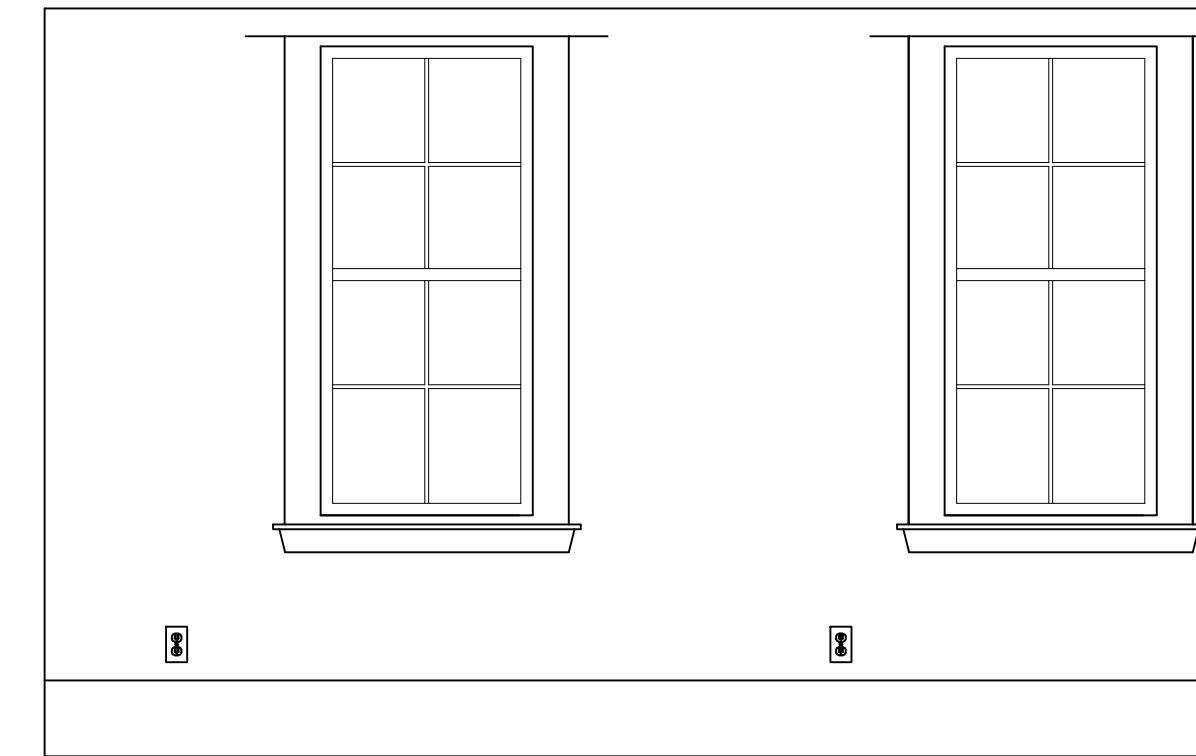

INTERIOR WALL "D"



© 2019 AEC CONSULTANTS INC

ARCHITECTURAL AS BUILT

**Chadds Ford, PA 19317
Master Bedroom**

01	100% SUBMISSION	
NO.	ISSUES REVISIONS	DATE
SHEET TITLE		
HL	PROJECT MANAGER	
HL	PROJECT DIRECTOR	
012317-1	PROJECT NUMBER	
1/2"=1'-0"	SCALE	
CL	DRAWN BY	
	SHEET NUMBER	

AB-3