

AS-BUILT DOCUMENTATION


SEATTLE, WA 98122



100% SUBMITTAL

DRAWING INDEX

- C-1 COVER SHEET | DRAWING INDEX
- SL SYMBOLS LEGEND
- AB-1 BASEMENT FLOOR PLAN AND RCP
- AB-2 FIRST FLOOR PLAN AND RCP
- AB-3 SECOND FLOOR PLAN AND RCP

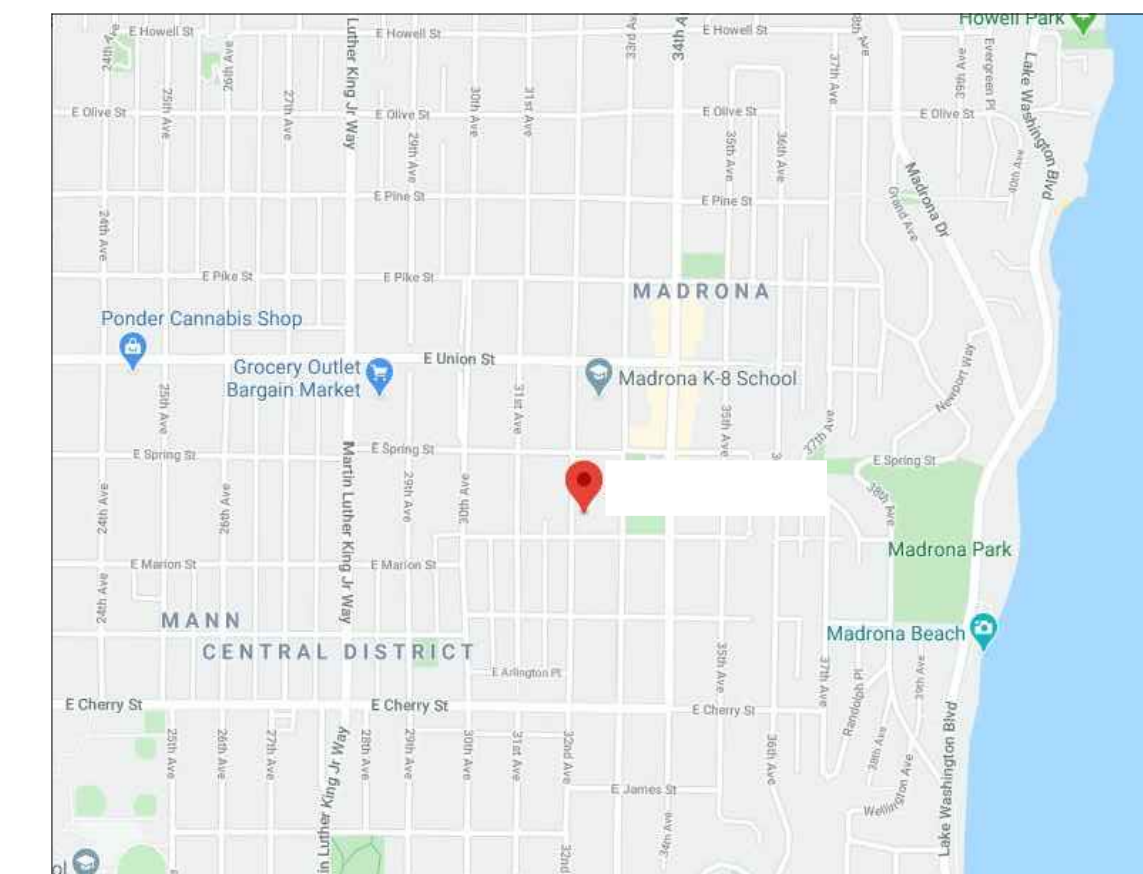

VICINITY MAP
NTS

AREA DATA	
BASEMENT	797 S.F. ±
FIRST FLOOR	971 S.F. ±
SECOND FLOOR	960 S.F. ±
GRAND TOTAL	2,728 S.F. ±

AS BUILT
PROFESSIONALS
www.asbuiltprofessionals.com
A DIVISION OF:

AEC
CONSULTANTS INC
844.272.8458
844 ASBUILT

© 2020 AEC CONSULTANTS INC

ARCHITECTURAL AS BUILT

SEATTLE, WA 98122

01	100% SUBMISSION	
NO.	ISSUES REVISIONS	DATE
SHEET TITLE		
COVER SHEET		
HL		PROJECT MANAGER
HL		PROJECT DIRECTOR
		PROJECT NUMBER
		SCALE
MM		DRAWN BY
		SHEET NUMBER

C-1

SYMBOLS LEGEND

RCP

- EXHAUST VENT
- CEILING MOUNTED LIGHT FIXTURE
- CEILING MOUNTED DIRECTIONAL LIGHT
- RECESSED CAN LIGHT
- EYEBALL OR SMALL CAN LIGHT
- PENDANT LIGHT
- INDIVIDUAL FLUOR. LAY-IN FIXTURE 4 BULB
- INDIVIDUAL FLUOR. HANGING FIXTURE 2 BULB
- INDIVIDUAL FLUOR. FLUSH MOUNT FIXTURE 4 BULB
- CAMERA
- MOTION DET.
- SUPPLY VENT
- SUPPLY VENT
- RETURN VENT
- RETURN VENT
- SPEAKER

- TRACK LIGHT OR VANITY LIGHT
- WALL-MOUNTED LIGHT FIXTURE
- EMERGENCY EXIT SIGN
- EMERGENCY EXIT LIGHT
- EMERGENCY EXIT LIGHT W/ SIGN
- LIGHTED STAIR SIGN
- FLOOD LIGHT
- PHOTO CELL
- CEILING FAN
- CEILING FAN W/ LIGHT KIT
- 7-2-6 CEILING HEIGHT AND TRIM 7'-2" ABOVE FLOOR BELOW WITH 6" CROWN MOULDING. NOTE: ALL CEILINGS NOT LABELED ARE PLASTER. CEILINGS SHOWN WITH A GRID ARE LAY IN ACOUSTICAL TILE..
- JUNCTION BOX

ELECTRIC

- DATA OUTLET
- TELEPHONE JACK
- ELECTRIC SWITCH
- CABLE TELEVISION OUTLET
- DUPLEX RECEPTACLE OUTLET
- SPECIAL PURPOSE CONNECTION OR OUTLET
- QUADRUPLEX RECEPTACLE OUTLET
- FLOOR DUPLEX RECEPTACLE OUTLET
- ELECTRIC PANEL
- ELECTRIC METER
- BUTTON SWITCH
- DISCONNECT SWITCH
- GROUND/FLOOR LIGHT
- KEY PAD

FIRE PROTECTION


- FIRE EXTINGUISHER
- FIRE PULL
- FIRE ALARM (HORN/SRTOBE)
- SMOKE DETECTOR
- SMOKE ALARM SPEAKER
- SPRINKLER HEAD CEILING MOUNT
- SPRINKLER HEAD WALL MOUNT

MEP


- THERMOSTAT
- FLOOR DRAIN
- VALVE
- HOSE BIB
- WATER SUPPLY
- SUSPENDED GAS HEATER

MISC

- BOLLARD
- 11-4-11/16 SPOT ELEVATION

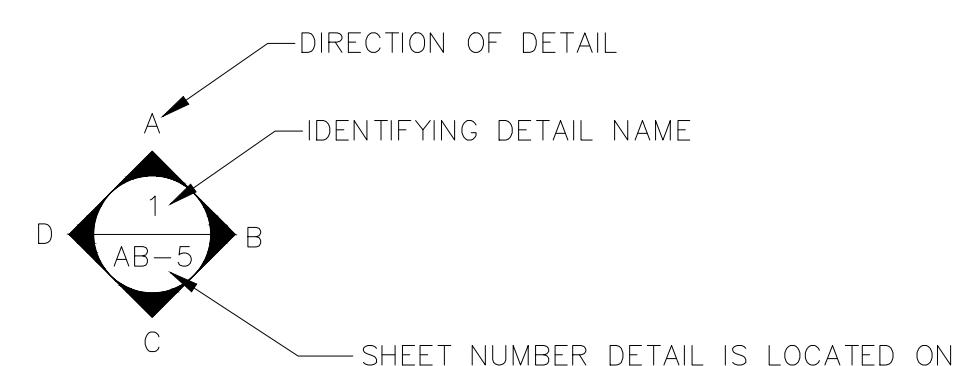

INTERIOR ELEVATIONS

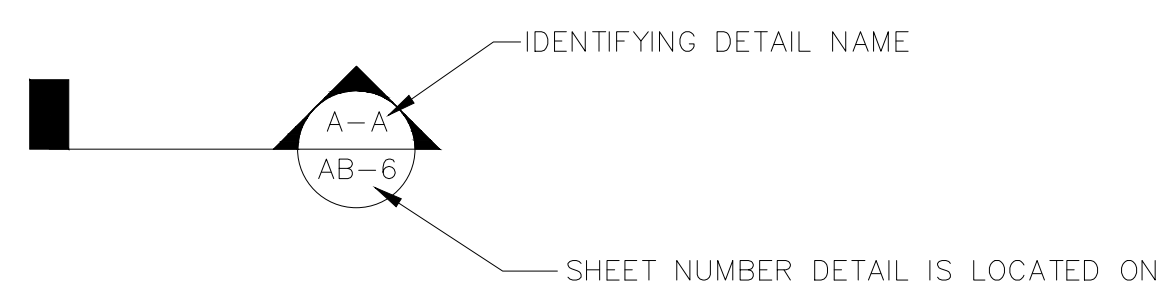

BUILDING SECTION

PHOTO DOCUMENTATION LEGEND

- INDICATES LOCATION OF CAMERA
- INDICATES DIRECTION OF CAMERA LENS AND CORRESPONDING PHOTO / VIDEO NUMBER

TYPES OF DOCUMENTATION


- 001 GROUND BASED PHOTO
- V-001 GROUND BASED VIDEO
- 360° SPHERICAL PHOTO
- 000 AERIAL BASED PHOTO
- V-000 AERIAL BASED VIDEO

01	100% SUBMISSION	
NL	ISSUES REVISIONS	DATE
		SHEET TITLE
HL		PROJECT MANAGER
HL		PROJECT DIRECTOR
		PROJECT NUMBER
		SCALE
MM		DRAWN BY
		SHEET NUMBER


SL

ARCHITECTURAL AS BUILT

SEATTLE, WA 98122

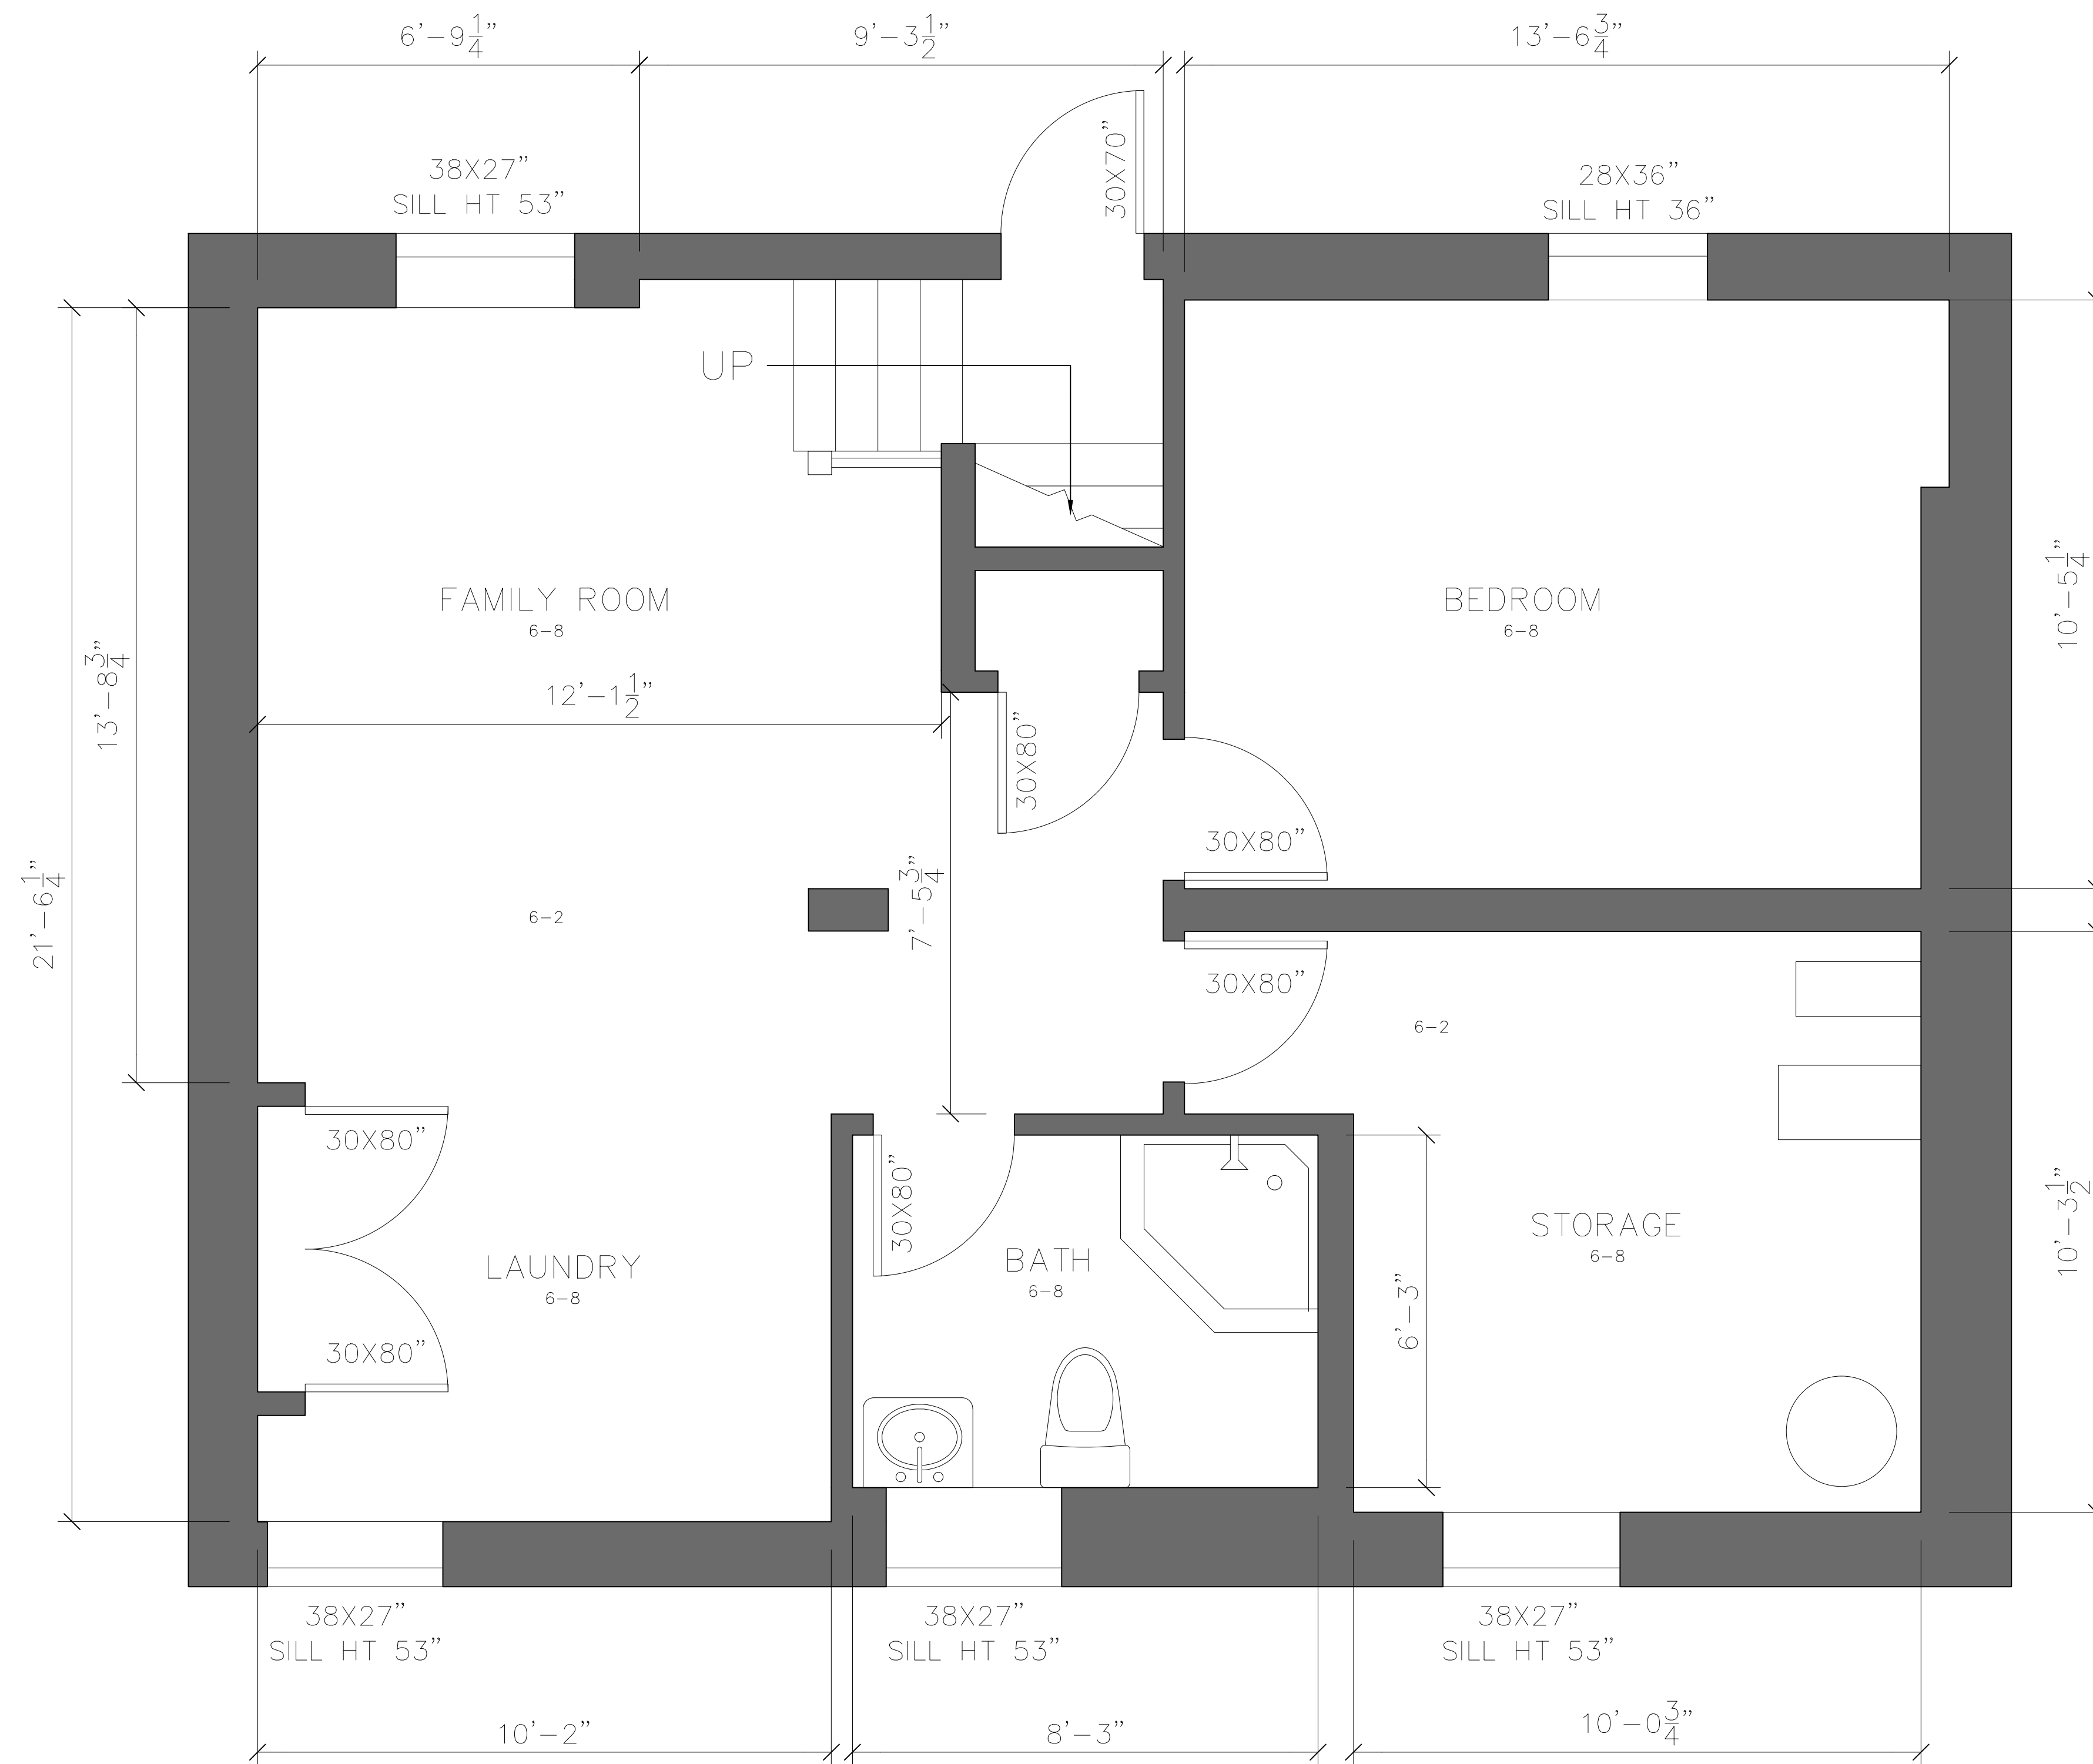

BASEMENT - PLAN

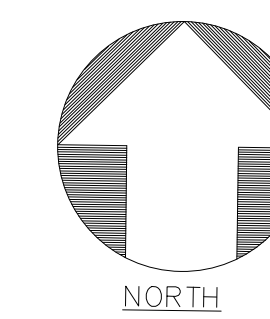

ARCHITECTURAL AS BUILT

SEATTLE, WA 98122


01	100% SUBMISSION	
NL	ISSUES REVISIONS	DATE

BASEMENT FLOOR PLAN & RCP


HL	PROJECT MANAGER
HL	PROJECT DIRECTOR
	PROJECT NUMBER
	SCALE
MM	DRAWN BY
	SHEET NUMBER

1/2"=1'-0"

AB-1

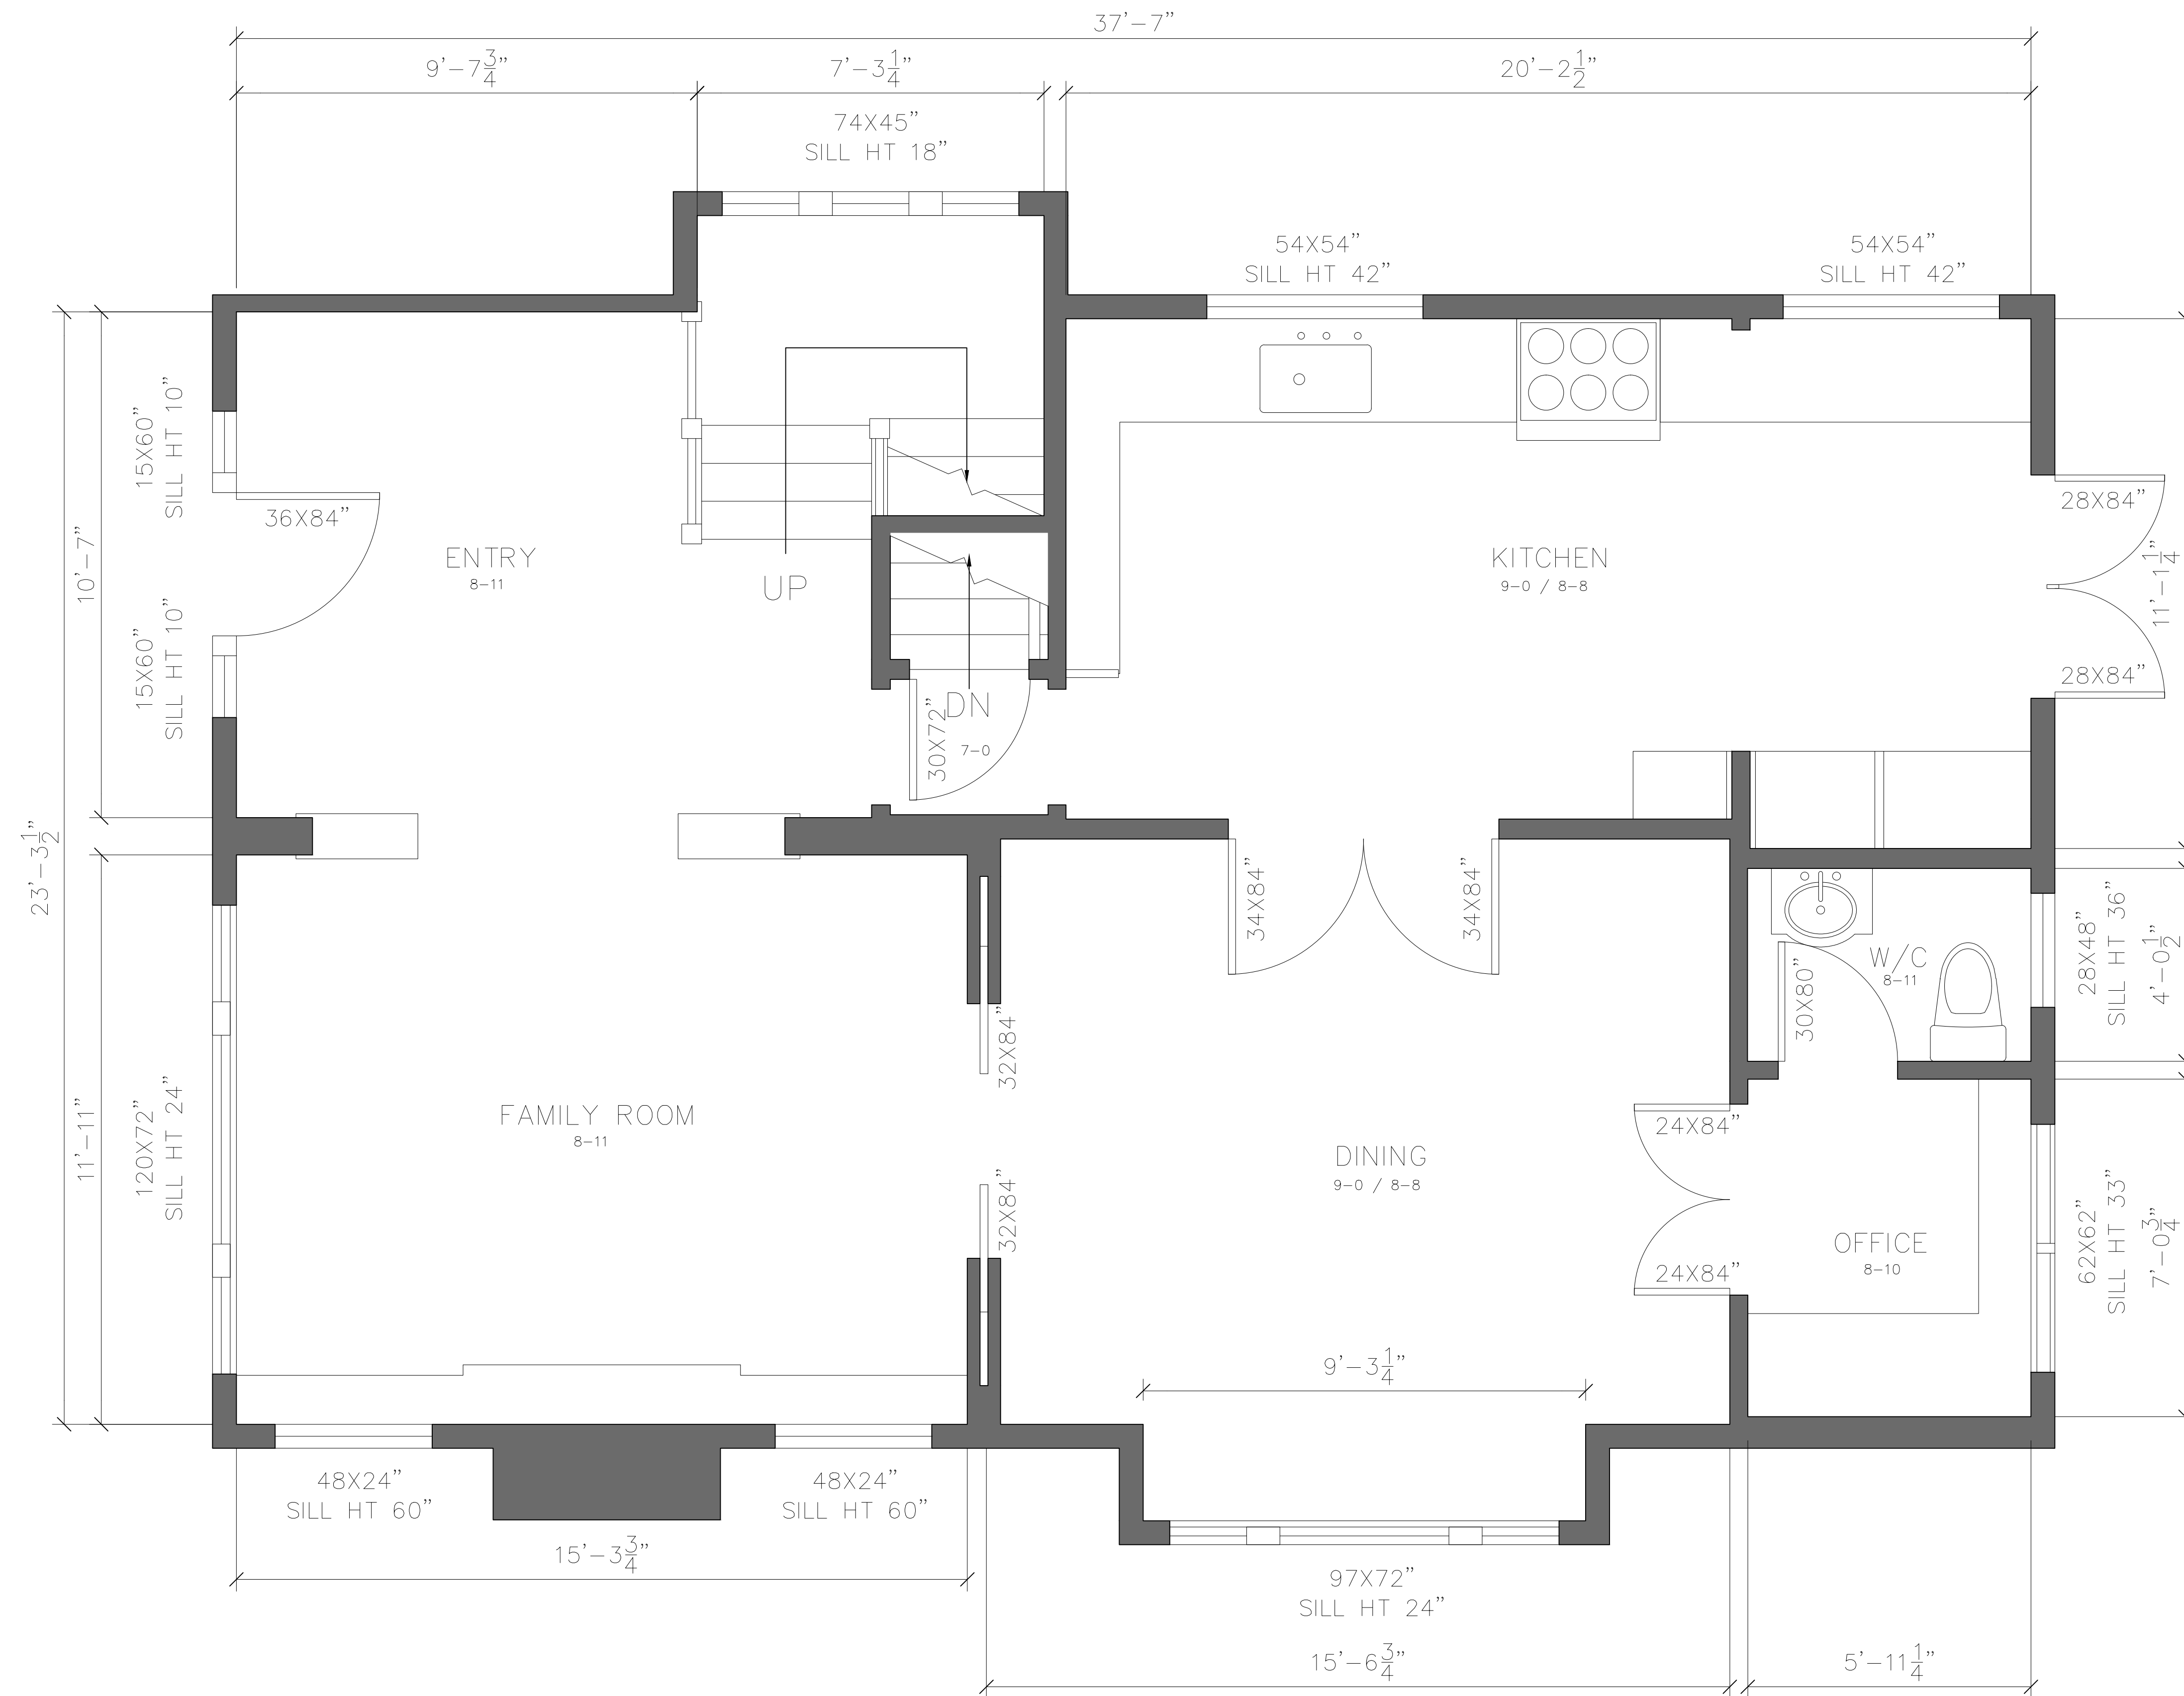

FIRST FLOOR – PLAN

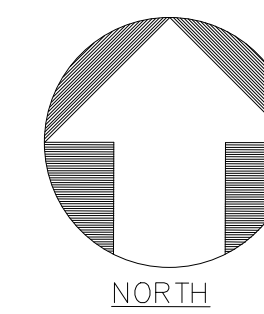

ARCHITECTURAL AS BUILT


SEATTLE, WA 98122

NO.	ISSUES REVISIONS	DATE
01	100% SUBMISSION	


**FIRST FLOOR
PLAN & RCP**

HL	PROJECT MANAGER
HL	PROJECT DIRECTOR
	PROJECT NUMBER
1/2"=1'-0"	SCALE
MM	DRAWN BY
	SHEET NUMBER

AB-2

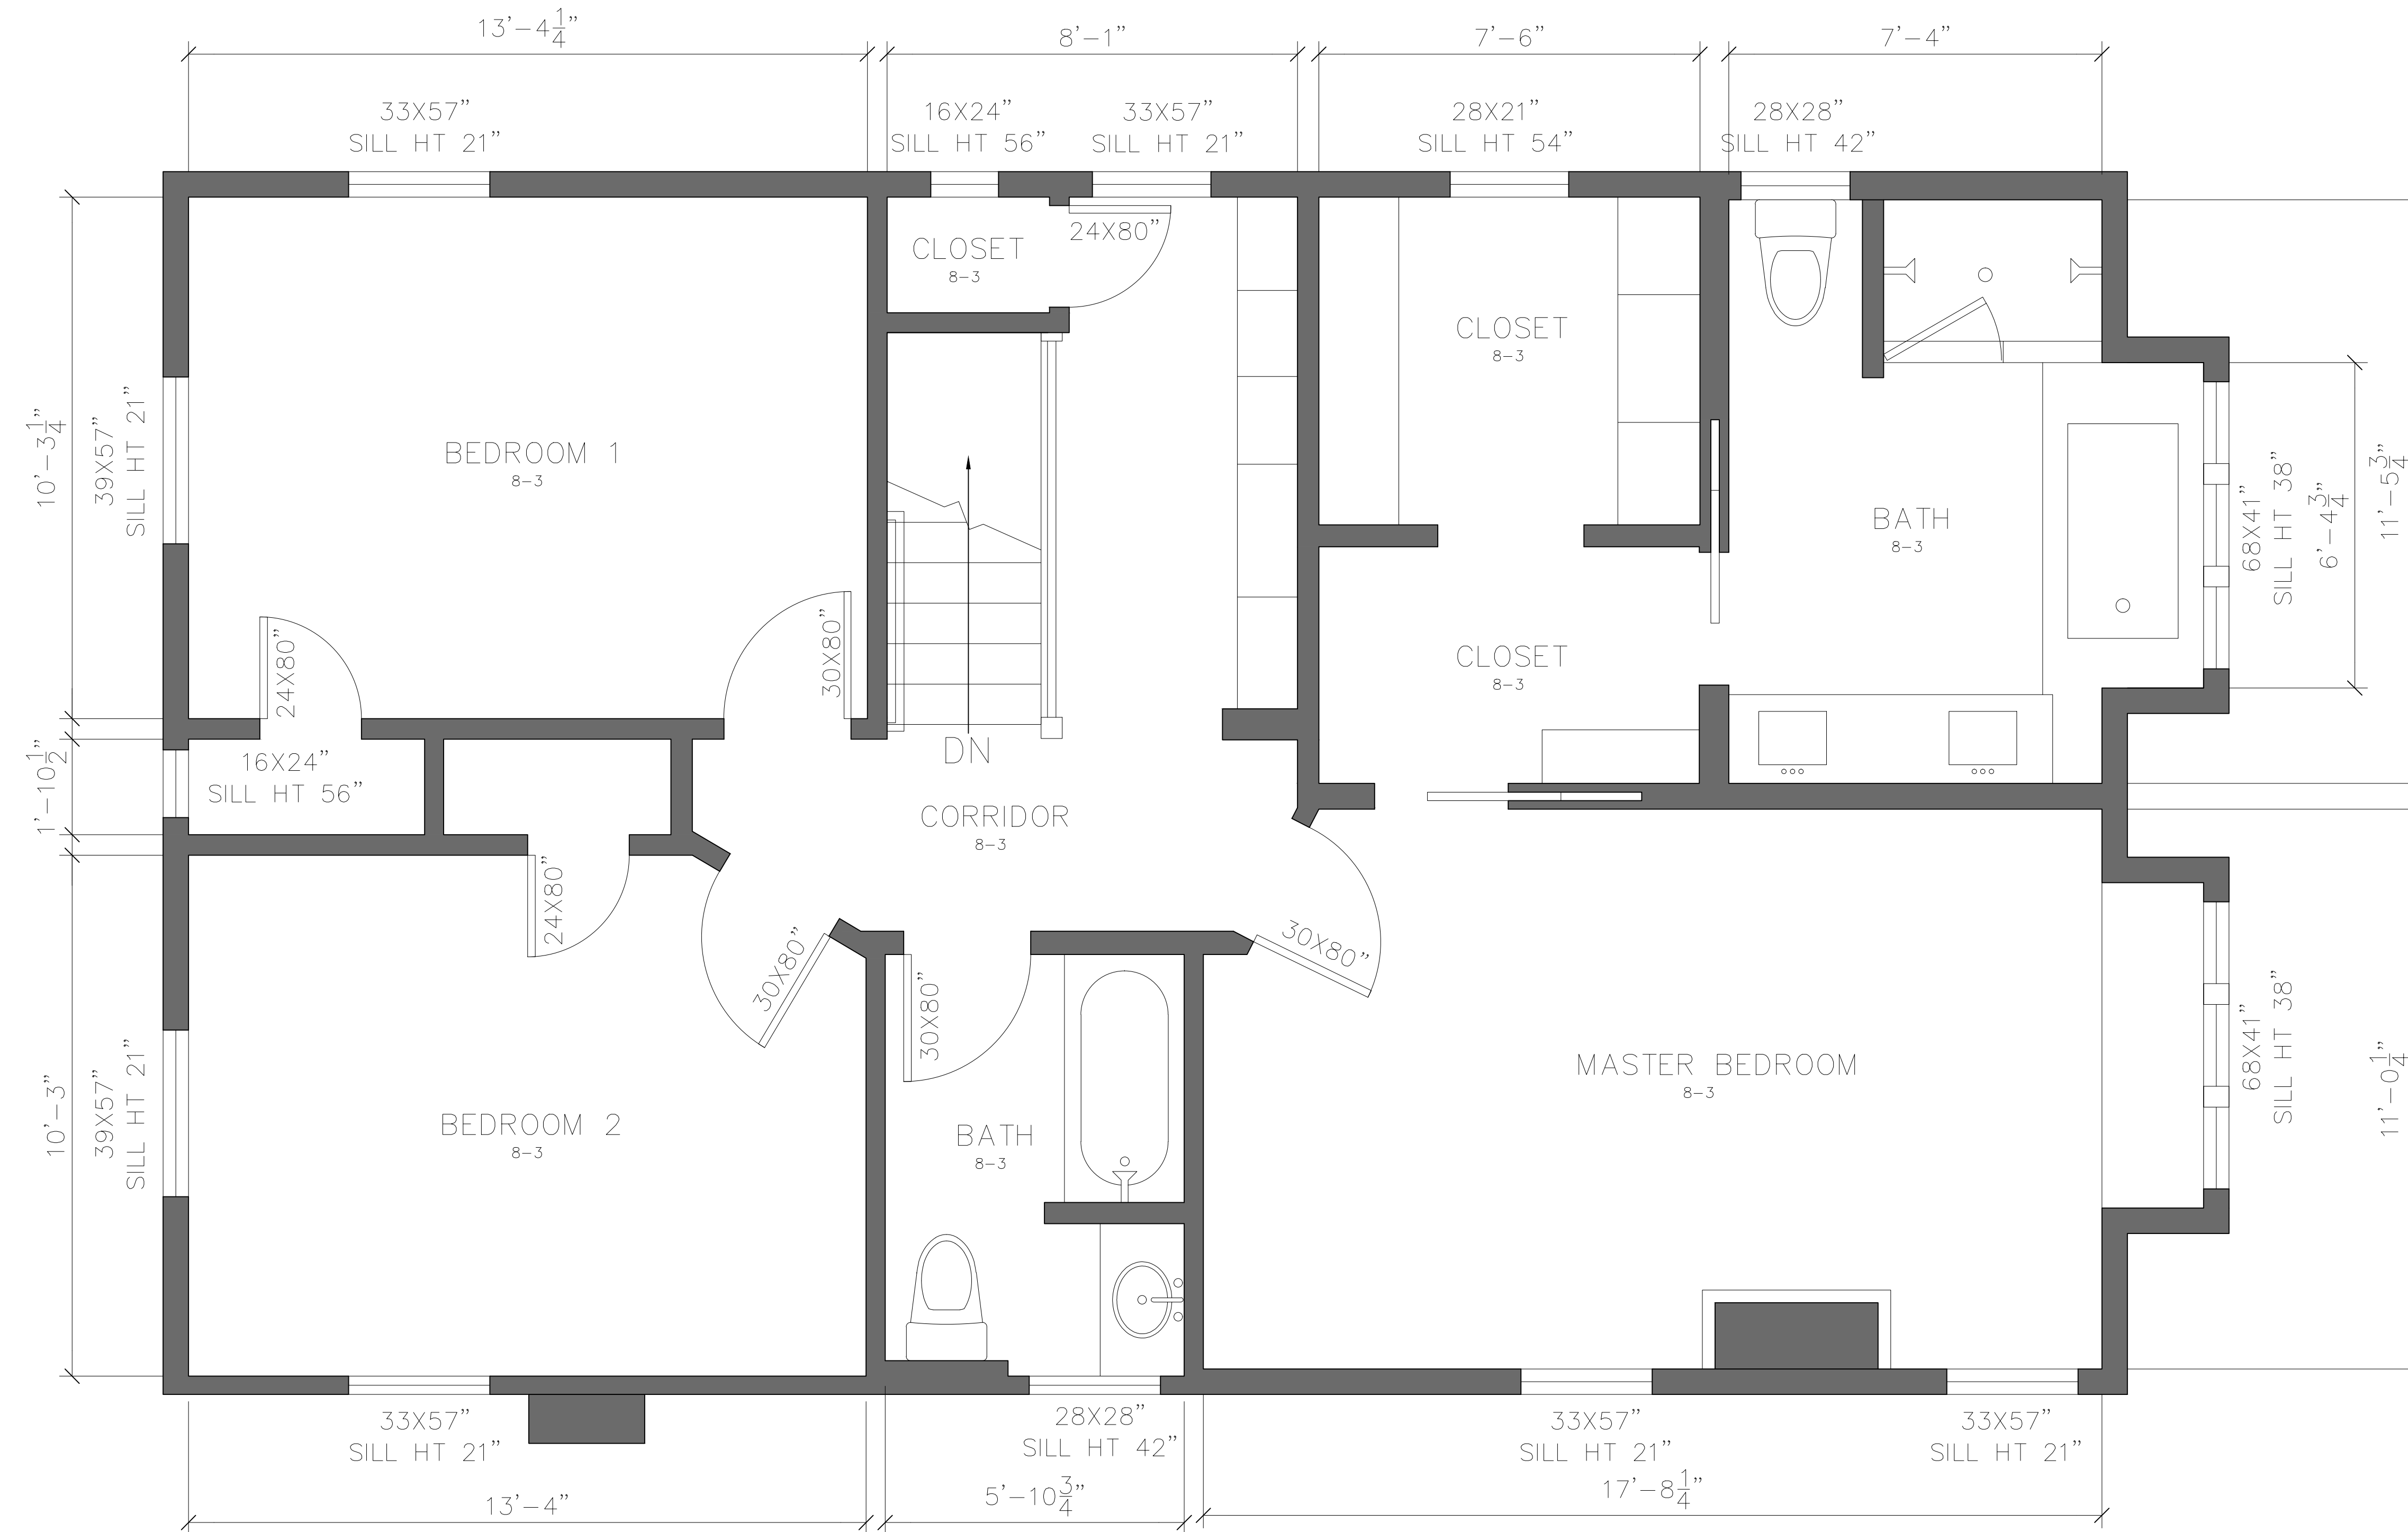

SECOND FLOOR - PLAN

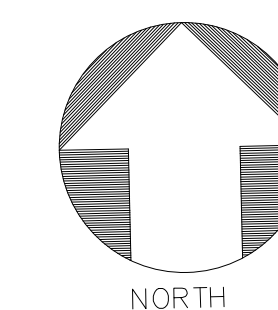

ARCHITECTURAL AS BUILT

SEATTLE, WA 98122

NO.	ISSUES REVISIONS	DATE
01	100% SUBMISSION	

SECOND FLOOR PLAN & RCP

HL	PROJECT MANAGER
HL	PROJECT DIRECTOR
	PROJECT NUMBER
1/2"=1'-0"	SCALE
MM	DRAWN BY
	SHEET NUMBER

AB-3