

 

AS-BUILT DOCUMENTATION



100% SUBMITTAL

DRAWING INDEX

C-1	COVER SHEET DRAWING INDEX
SL	SYMBOLS LEGEND
AB-1	1ST FLOOR PLAN
AB-2	2ND FLOOR PLAN

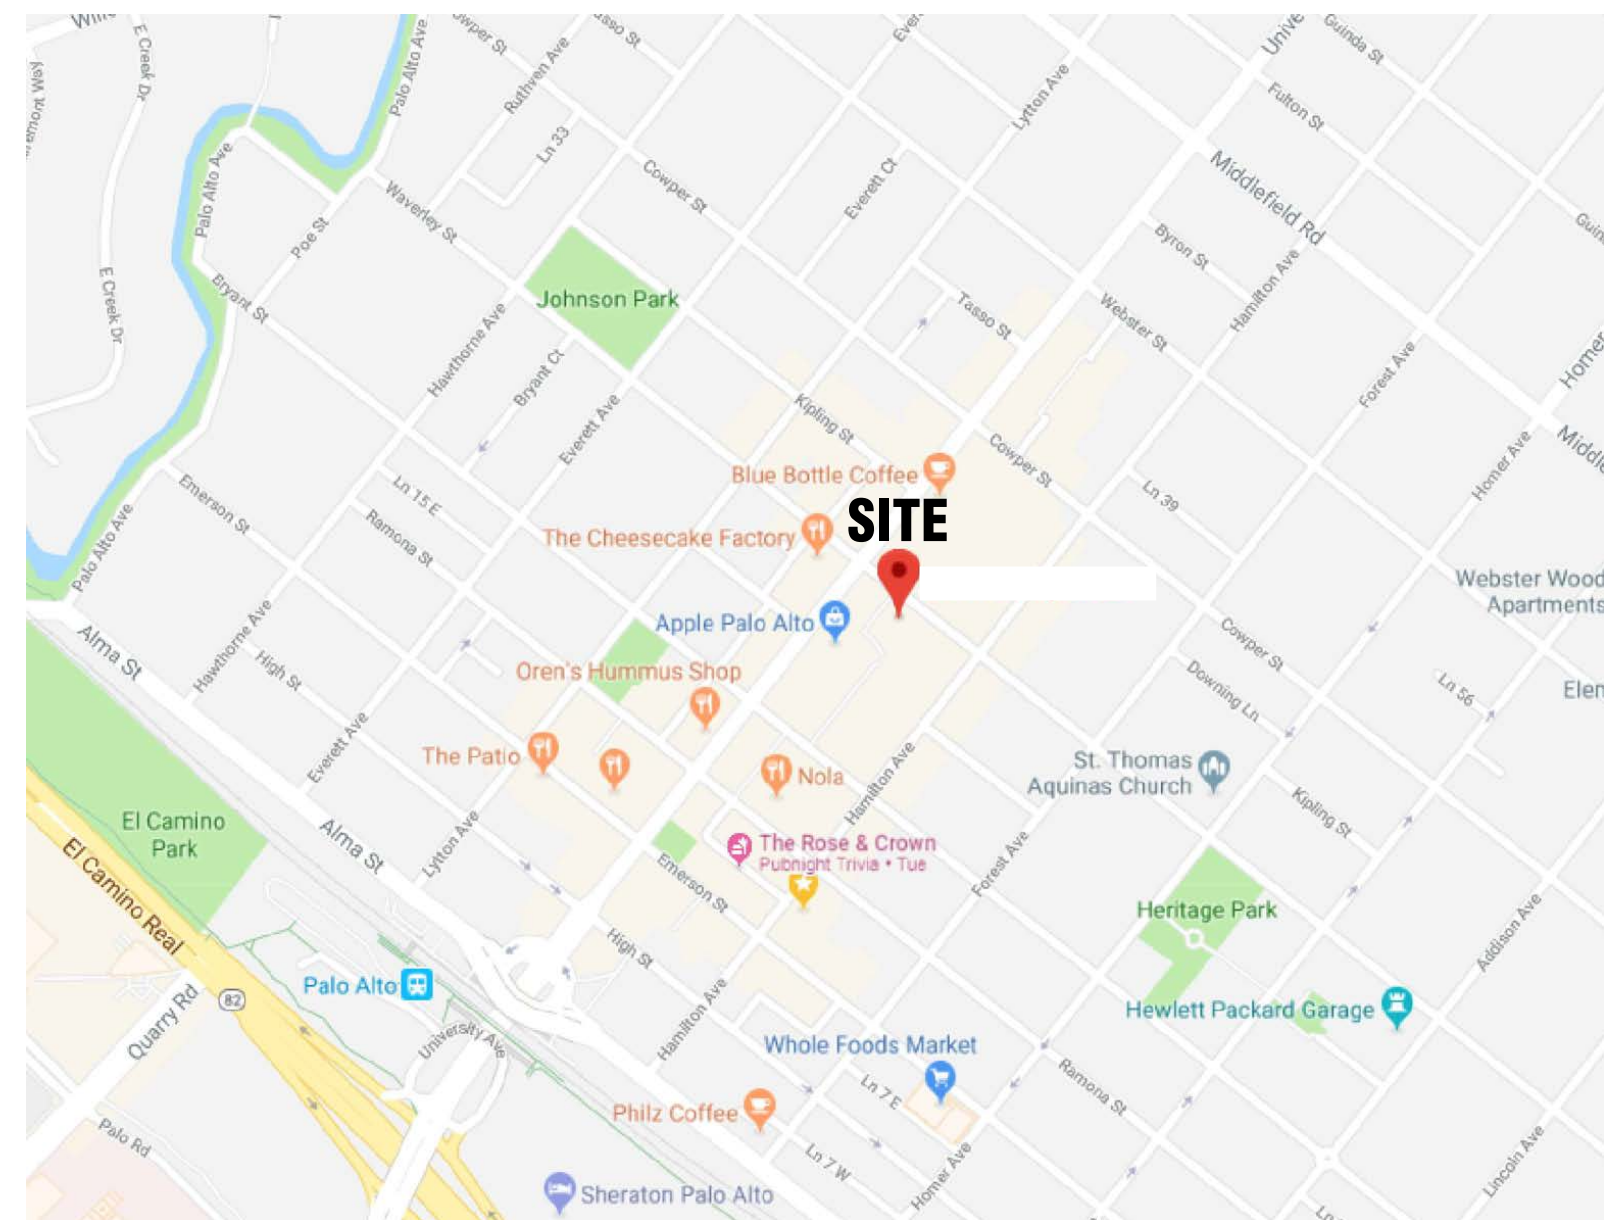

VICINITY MAP

<u>AREA DATA</u>	
FIRST FLOOR	5,982 S.F. ±
SECOND FLOOR	3,074 S.F. ±
GRAND TOTAL	9,056 S.F. ±



© 2017 AEC CONSULTANTS INC

ARCHITECTURAL AS BUILT

Palo Alto, CA 94301

01	100% SUBMISSION		SEE COVER SHEET
NO.	ISSUES REVISIONS		DATE
		SHEET TITLE	
<div>Cover Sheet Content Area COVER SHEET</div>			
HL		PROJECT MANAGER	
HL		PROJECT DIRECTOR	
012317-1		PROJECT NUMBER	
		SCALE	
MM		DRAWN BY	
		SHEET NUMBER	

C-1

SYMBOLS LEGEND

RCP

	EXHAUST VENT		TRACK LIGHT OR VANITY LIGHT
	CEILING MOUNTED LIGHT FIXTURE		WALL-MOUNTED LIGHT FIXTURE
	CEILING MOUNTED DIRECTIONAL LIGHT		EMERGENCY EXIT SIGN
	RECESSED CAN LIGHT		EMERGENCY EXIT LIGHT
	EYEBALL OR SMALL CAN LIGHT		EMERGENCY EXIT LIGHT W/ SIGN
	PENDANT LIGHT		LIGHTED STAIR SIGN
	INDIVIDUAL FLUOR. LAY-IN FIXTURE 4 BULB		FLOOD LIGHT
	INDIVIDUAL FLUOR. HANGING FIXTURE 2 BULB		PHOTO CELL
	INDIVIDUAL FLUOR. FLUSH MOUNT FIXTURE 4 BULB		CEILING FAN
	CAMERA		CEILING FAN W/ LIGHT KIT
	MOTION DET.		CEILING HEIGHT AND TRIM 7'-2" ABOVE FLOOR BELOW WITH 6" CROWN MOULDING. NOTE: ALL CEILINGS NOT LABELED ARE PLASTER. CEILINGS SHOWN WITH A GRID ARE LAY IN ACOUSTICAL TILE..
	SUPPLY VENT		JUNCTION BOX
	SUPPLY VENT		
	RETURN VENT		
	RETURN VENT		
	SPEAKER		

ELECTRIC

	DATA OUTLET
	TELEPHONE JACK
	ELECTRIC SWITCH
	CABLE TELEVISION OUTLET
	DUPLEX RECEPTACLE OUTLET
	SPECIAL PURPOSE CONNECTION OR OUTLET
	QUADRUPLIX RECEPTACLE OUTLET
	FLOOR DUPLEX RECEPTACLE OUTLET
	ELECTRIC PANEL
	ELECTRIC METER
	BUTTON SWITCH
	DISCONNECT SWITCH
	GROUND/FLOOR LIGHT
	KEY PAD

FIRE PROTECTION


	FIRE EXTINGUISHER
	FIRE PULL
	FIRE ALARM (HORN/SRTOBE)
	SMOKE DETECTOR
	SMOKE ALARM SPEAKER
	SPRINKLER HEAD CEILING MOUNT
	SPRINKLER HEAD WALL MOUNT

MEP


	THERMOSTAT
	FLOOR DRAIN
	VALVE
	HOSE BIB
	WATER SUPPLY
	SUSPENDED GAS HEATER

MISC

	BOLLARD
	11-4-11/16SPOT ELEVATION

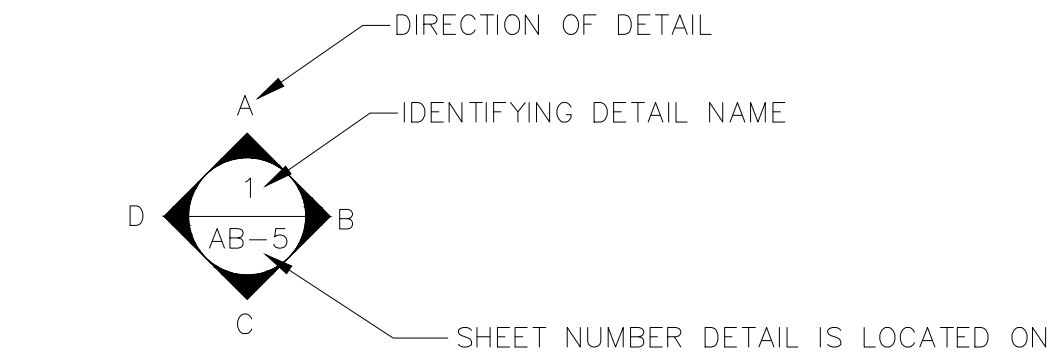

INTERIOR ELEVATIONS

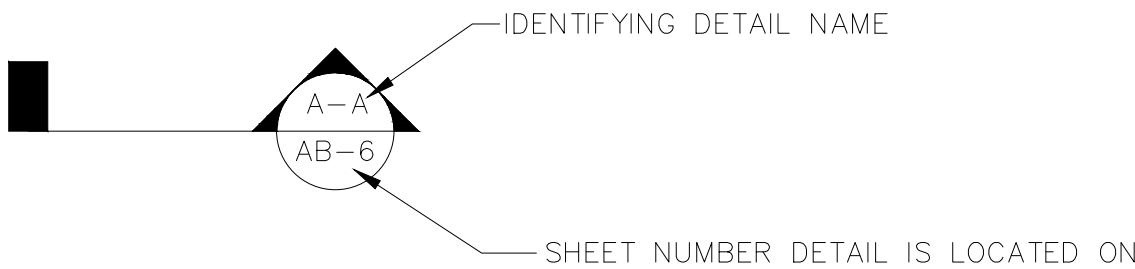

BUILDING SECTION

PHOTO DOCUMENTATION LEGEND

INDICATES LOCATION OF CAMERA

INDICATES DIRECTION OF CAMERA LENS AND CORRESPONDING PHOTO / VIDEO NUMBER

TYPES OF DOCUMENTATION

001 GROUND BASED PHOTO

V-001 GROUND BASED VIDEO

123 360° SPHERICAL PHOTO

000 AERIAL BASED PHOTO

V-000 AERIAL BASED VIDEO

AS BUILT PROFESSIONALS

www.asbuiltprofessionals.com

A DIVISION OF:

AEC CONSULTANTS INC

844.272.8458

844 AS BUILT

© 2017 AEC CONSULTANTS INC

ARCHITECTURAL AS BUILT


Palo Alto, CA 94301

01	100% SUBMISSION	SEE COVER SHEET
NO.	ISSUES REVISIONS	DATE
		SHEET TITLE
HL	PROJECT MANAGER	
HL	PROJECT DIRECTOR	
012317-1	PROJECT NUMBER	
NOT TO SCALE		SCALE
MM	DRAWN BY	
		SHEET NUMBER

SL



 
AB-1



Palo Alto, CA 94301



AB-2

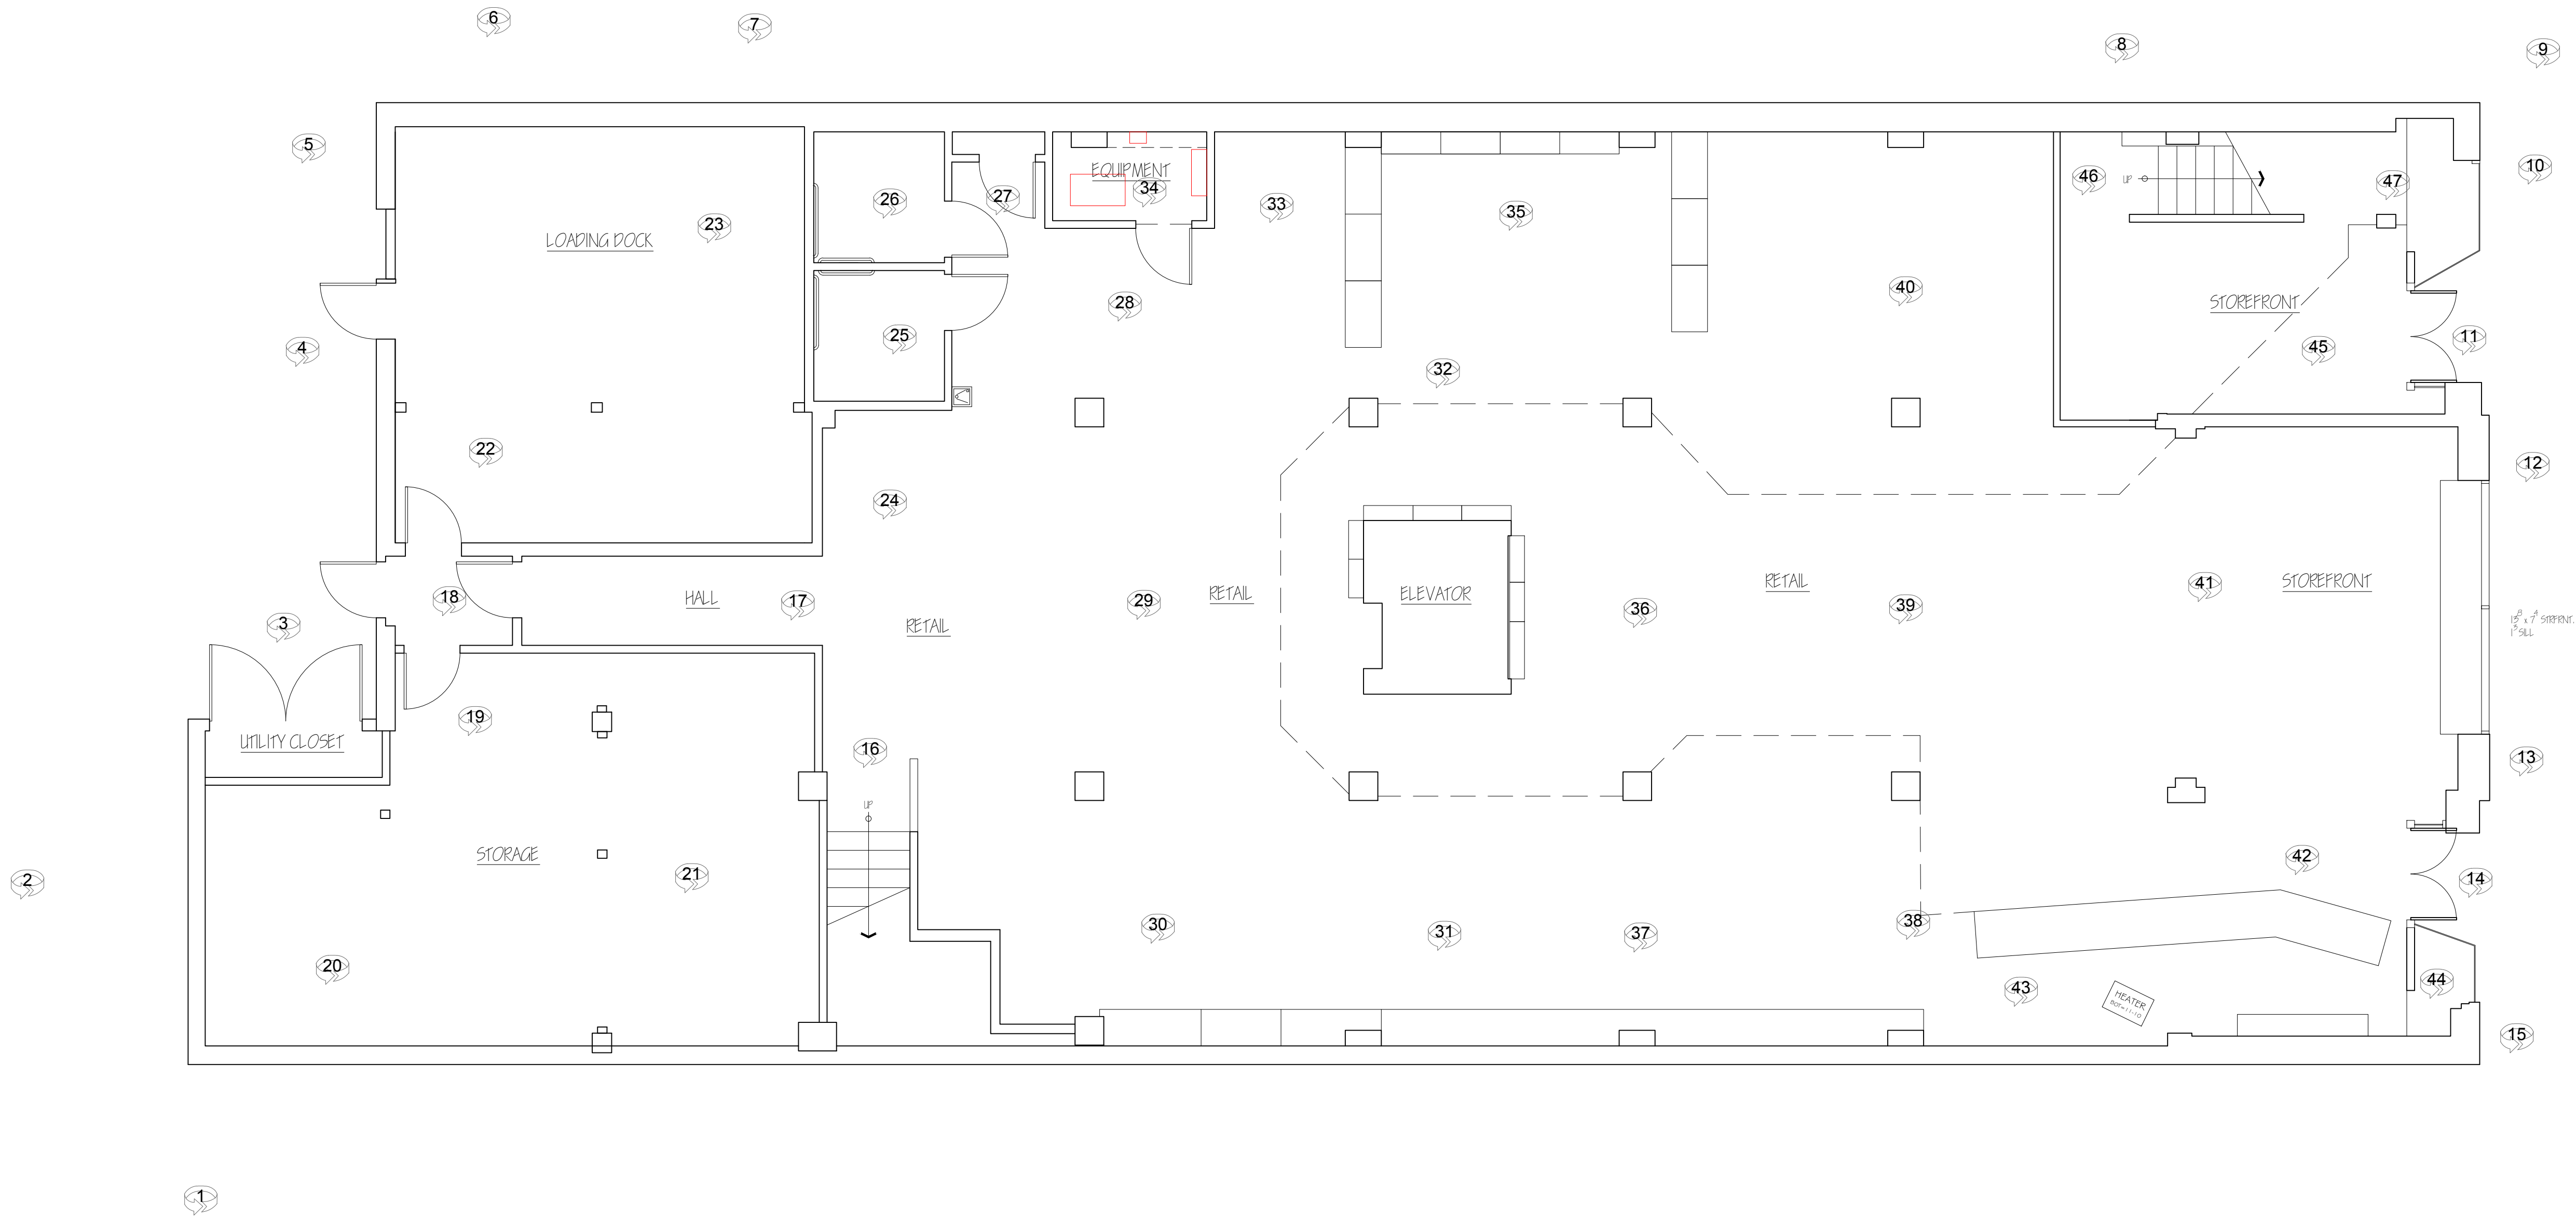

FIRST FLOOR PLAN

PHOTO DOCUMENTATION LEGEND

INDICATES LOCATION OF CAMERA

INDICATES DIRECTION OF CAMERA LENS AND CORRESPONDING PHOTO / VIDEO NUMBER

TYPES OF DOCUMENTATION

001	V-001	000	000	V-000
GROUND BASED PHOTO	GROUND BASED VIDEO	360° SPHERICAL PHOTO	AERIAL BASED PHOTO	AERIAL BASED VIDEO

AS BUILT PROFESSIONALS
www.asbuiltprofessionals.com
A DIVISION OF:

AEC CONSULTANTS INC

844.272.8458
844 ASBUILT


© 2017 AEC CONSULTANTS, INC

ARCHITECTURAL AS BUILT

Palo Alto, CA 94301

01	100% SUBMISSION	SEE COVER SHEET
NO.	ISSUES REVISIONS	DATE
SHEET TITLE		
HL		PROJECT MANAGER
HL		PROJECT DIRECTOR
012317-1		PROJECT NUMBER
3/16"=1'-0"		SCALE
MM		DRAWN BY
SHEET NUMBER		

AB-3

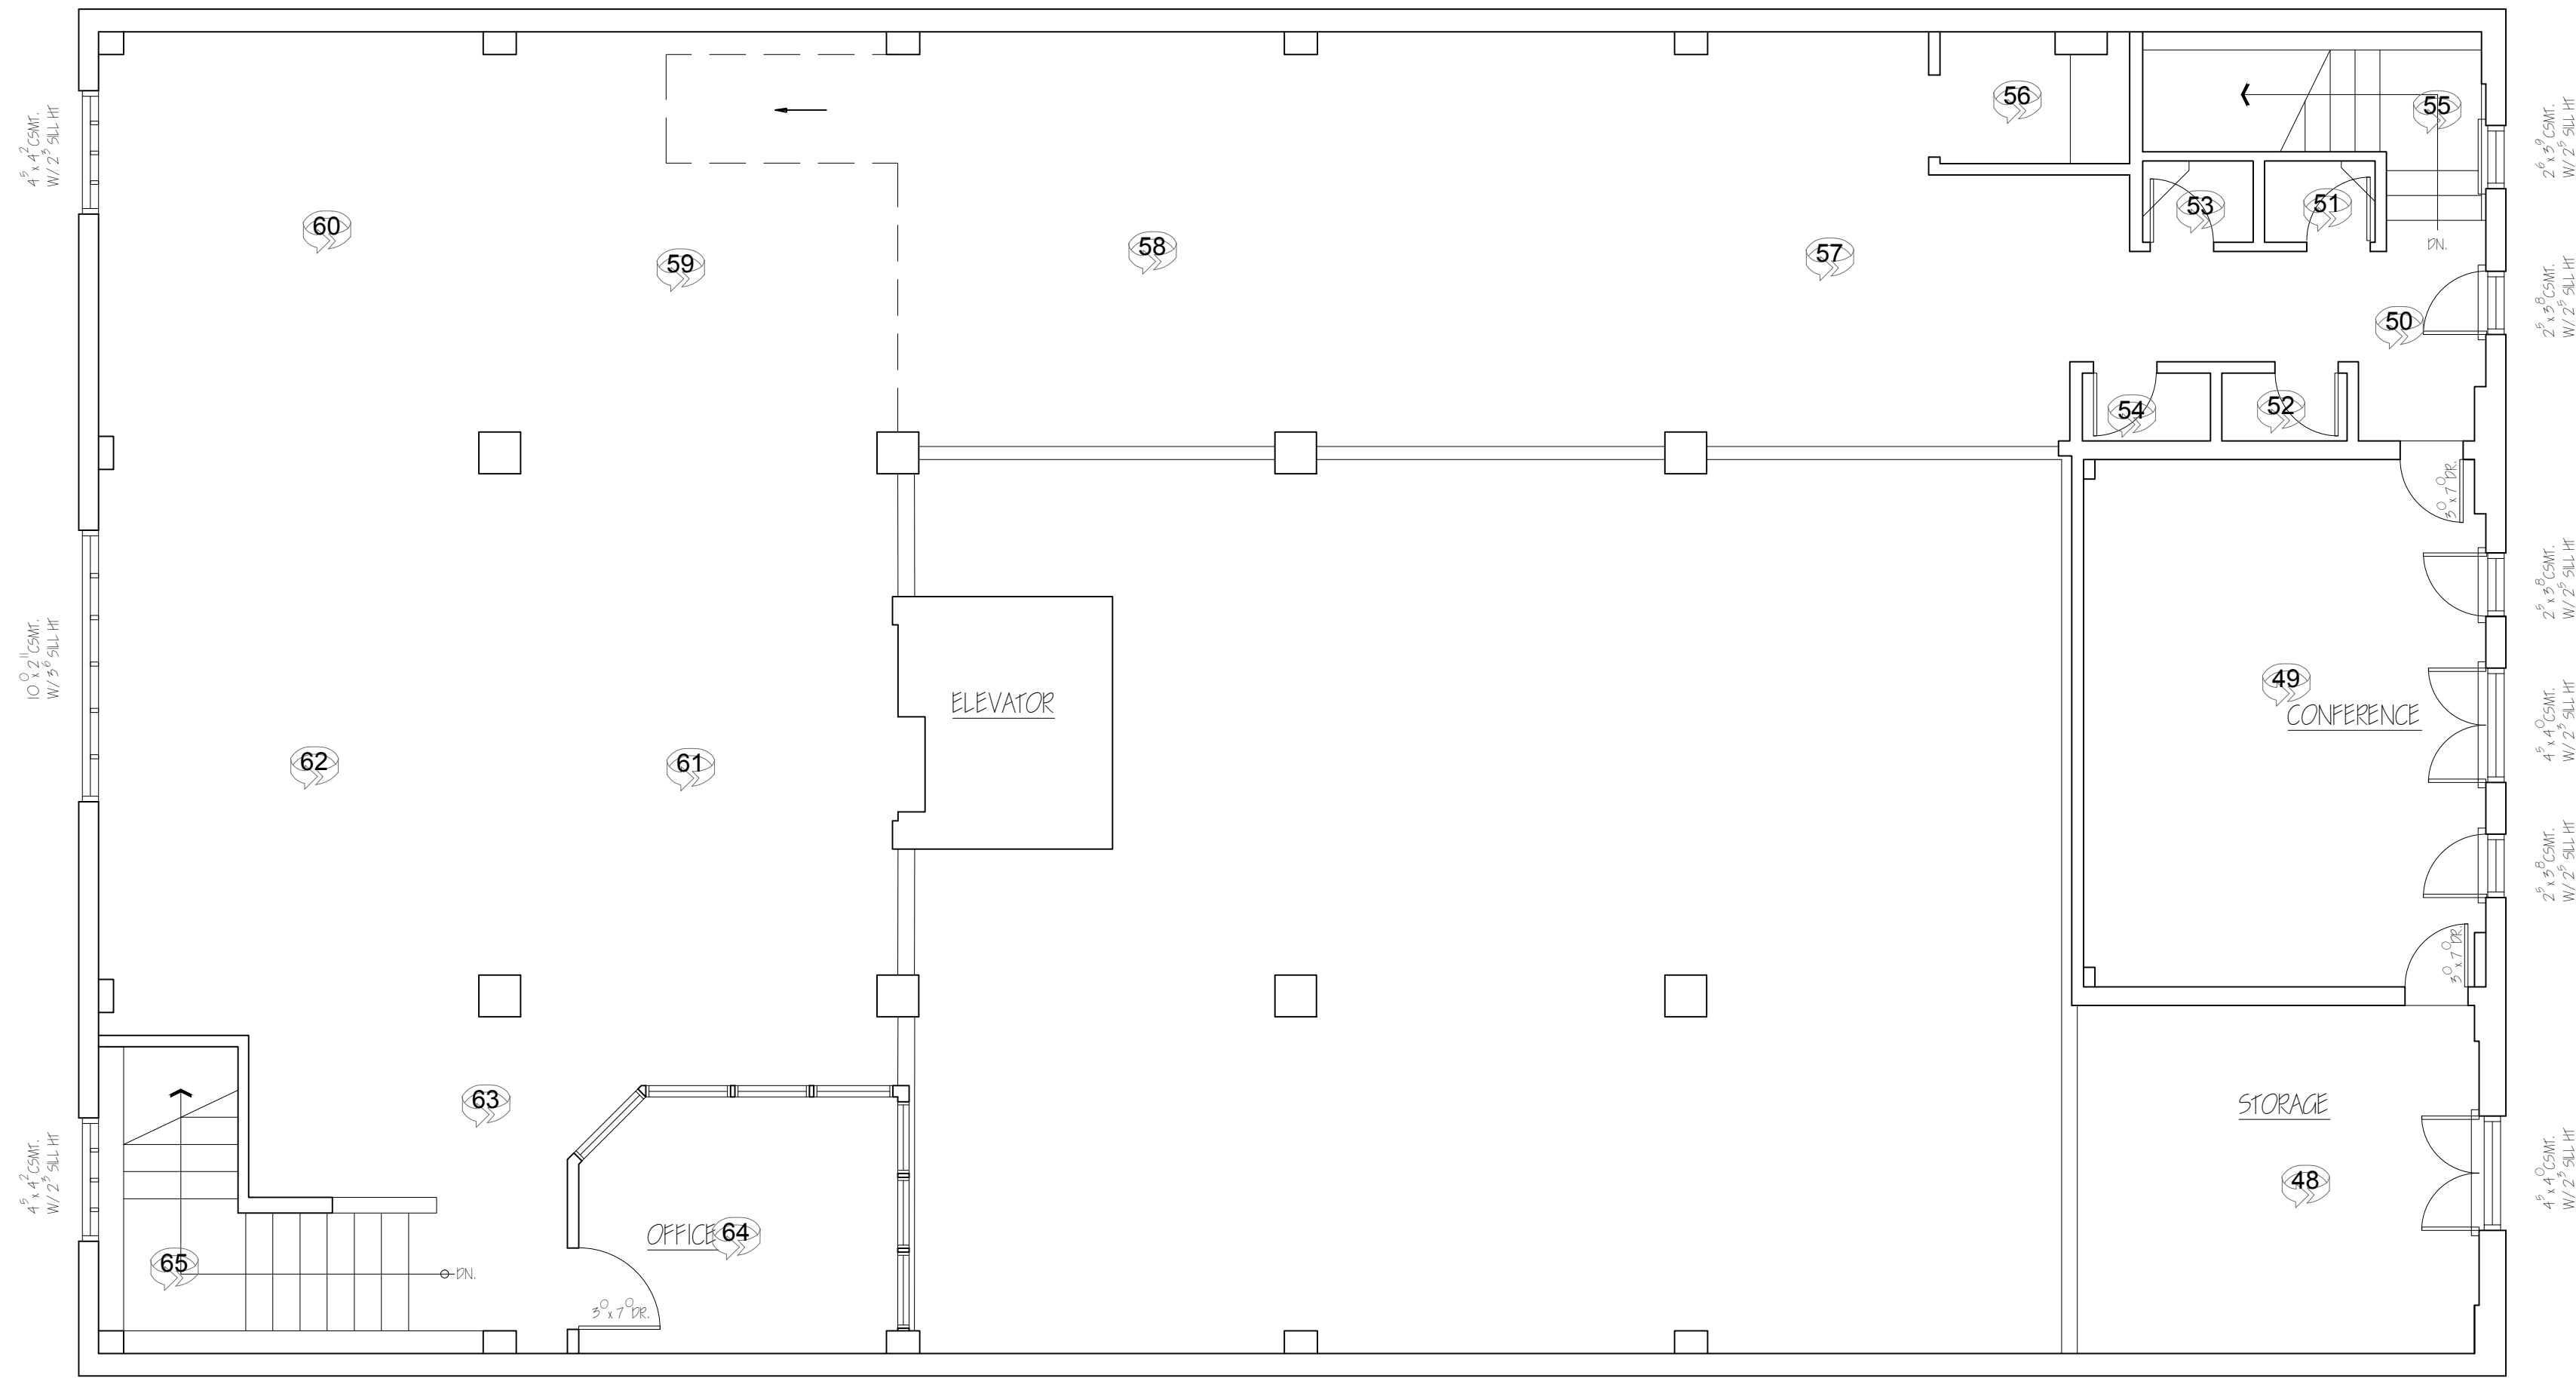

SECOND FLOOR PLAN

PHOTO DOCUMENTATION LEGEND

INDICATES LOCATION OF CAMERA

INDICATES DIRECTION OF CAMERA LENS AND CORRESPONDING PHOTO / VIDEO NUMBER

TYPES OF DOCUMENTATION

001

GROUND BASED PHOTO

V-001

GROUND BASED VIDEO

000


360° SPHERICAL PHOTO


000

AERIAL BASED PHOTO

V-000

AERIAL BASED VIDEO

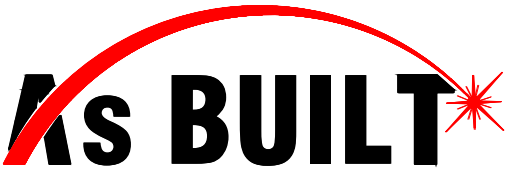**AS BUILT**
PROFESSIONALS
www.asbuiltprofessionals.com
A DIVISION OF:

**AEC**
CONSULTANTS INC.

844.272.8458
844 AS BUILT

© 2017 AEC CONSULTANTS INC.

ARCHITECTURAL AS BUILT

Palo Alto, CA 94301

01	100% SUBMISSION	SEE COVER SHEET
NO.	ISSUES REVISIONS	DATE
SHEET TITLE		
HL		PROJECT MANAGER
HL		PROJECT DIRECTOR
012317-1		PROJECT NUMBER
3/16"=1'-0"		SCALE
MM		DRAWN BY
SHEET NUMBER		

AB-4