

# AS-BUILT DOCUMENTATION

# Edgewood Shopping Center

Azusa CA 91702



## DRAWING INDEX


- C-1 COVER SHEET | DRAWING INDEX
- SL SYMBOLS LEGEND
- AB-1 FIRST FLOOR PLAN
- AB-2 SECOND FLOOR PLAN

**AS BUILT**  
PROFESSIONALS  
www.asbuiltprofessionals.com  
A DIVISION OF:

**AEC**  
CONSULTANTS INC  
844.272.8458  
844 AS BUILT

© 2017 AEC CONSULTANTS INC

**ARCHITECTURAL AS BUILT**  
**Edgewood Shopping Center**  
**Azusa CA 91702**

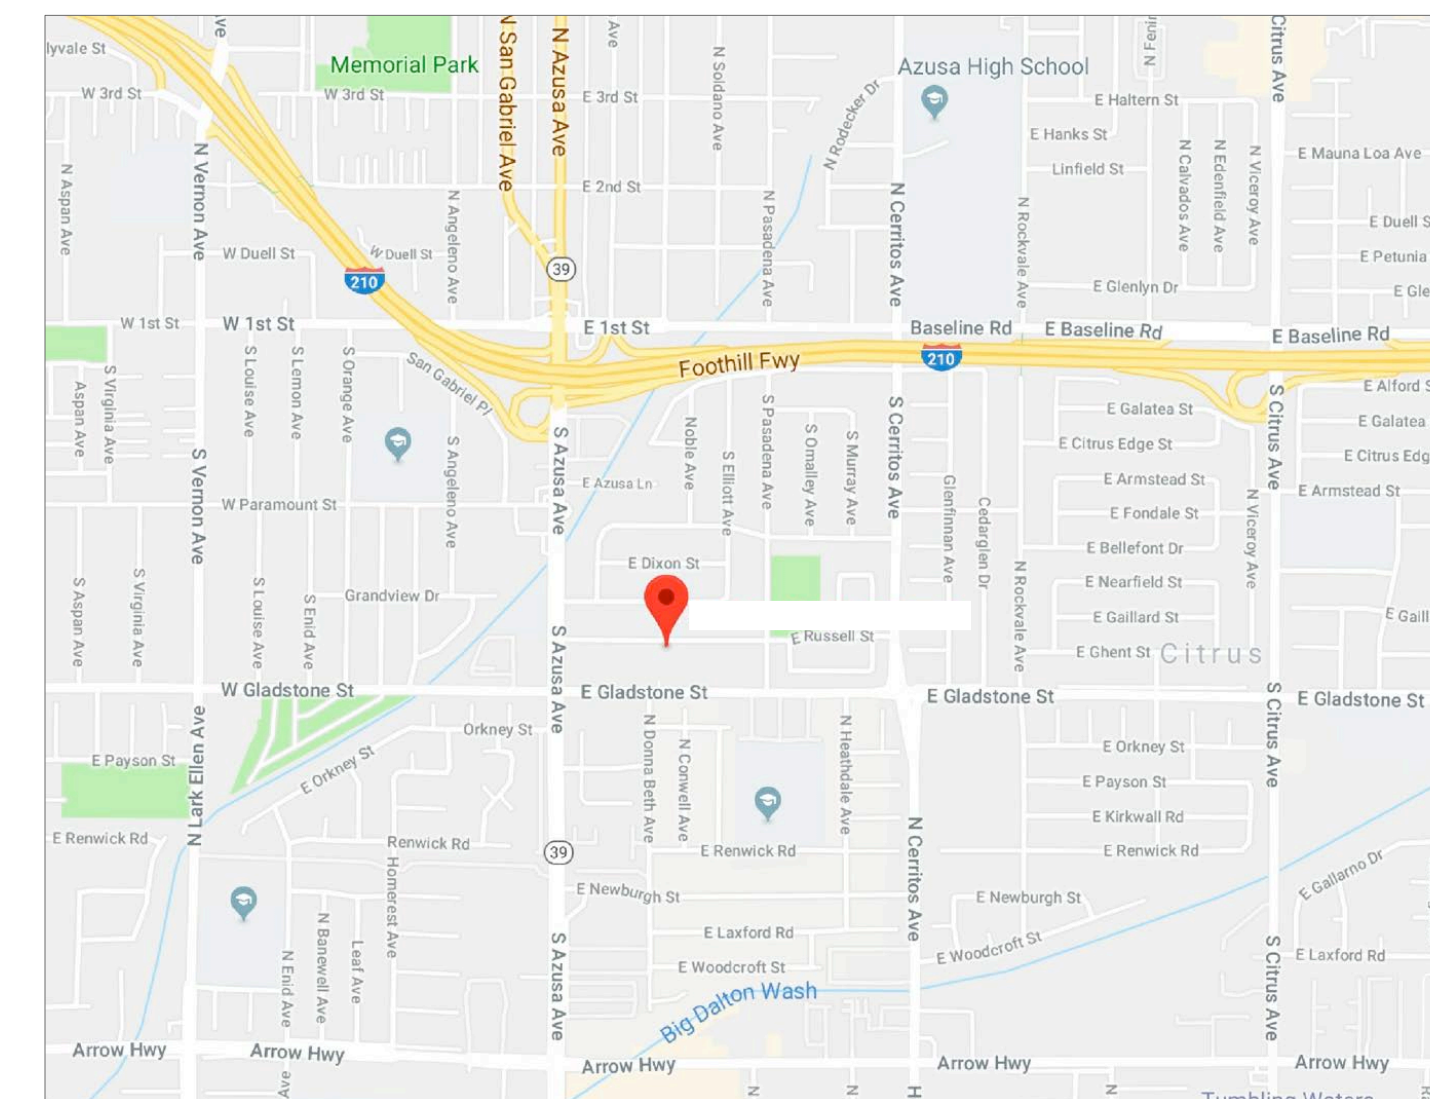

**VICINITY MAP**  
NTS

AREA DATA	
FIRST FLOOR	25,800 S.F. ±
SECOND FLOOR	6,878 S.F. ±
TOTAL	32,678 S.F. ±

**100% SUBMITTAL**

01	100% SUBMISSION	SEE COVER SHEET
NO.	ISSUES   REVISIONS	DATE
		SHEET TITLE

**COVER SHEET**

HL	PROJECT MANAGER
HL	PROJECT DIRECTOR
012317-1	PROJECT NUMBER
	SCALE
CL	DRAWN BY
	SHEET NUMBER

**C-1**



# SYMBOLS LEGEND

## RCP

	EXHAUST VENT		TRACK LIGHT OR VANITY LIGHT
	CEILING MOUNTED LIGHT FIXTURE		WALL-MOUNTED LIGHT FIXTURE
	CEILING MOUNTED DIRECTIONAL LIGHT		EMERGENCY EXIT SIGN
	RECESSED CAN LIGHT		EMERGENCY EXIT LIGHT
	EYEBALL OR SMALL CAN LIGHT		EMERGENCY EXIT LIGHT W/ SIGN
	PENDANT LIGHT		LIGHTED STAIR SIGN
	INDIVIDUAL FLUOR. LAY-IN FIXTURE 4 BULB		FLOOD LIGHT
	INDIVIDUAL FLUOR. HANGING FIXTURE 2 BULB		PHOTO CELL
	INDIVIDUAL FLUOR. FLUSH MOUNT FIXTURE 4 BULB		CEILING FAN
	CAMERA		CEILING FAN W/ LIGHT KIT
	MOTION DET.		
	SUPPLY VENT		
	SUPPLY VENT		
	RETURN VENT		
	RETURN VENT		
	SPEAKER		

7-2-6  
 CEILING HEIGHT AND TRIM 1'-2" ABOVE FLOOR BELOW WITH 6" CROWN MOULDING.  
 NOTE: ALL CEILINGS NOT LABELED ARE PLASTER. CEILINGS SHOWN WITH A GRID ARE LAY IN ACOUSTICAL TILE..

## ELECTRIC

	DATA OUTLET
	TELEPHONE JACK
	ELECTRIC SWITCH
	CABLE TELEVISION OUTLET
	DUPLEX RECEPTACLE OUTLET
	SPECIAL PURPOSE CONNECTION OR OUTLET
	QUADRUPLEX RECEPTACLE OUTLET
	FLOOR DUPLEX RECEPTACLE OUTLET
	ELECTRIC PANEL
	ELECTRIC METER
	BUTTON SWITCH
	DISCONNECT SWITCH
	GROUND/FLOOR LIGHT
	KEY PAD

## FIRE PROTECTION




	FIRE EXTINGUISHER
	FIRE PULL
	FIRE ALARM (HORN/SRTOBE)
	SMOKE DETECTOR
	SMOKE ALARM SPEAKER
	SPRINKLER HEAD CEILING MOUNT
	SPRINKLER HEAD WALL MOUNT

## MEP

	THERMOSTAT
	FLOOR DRAIN
	VALVE
	HOSE BIB
	WATER SUPPLY
	SUSPENDED GAS HEATER

## MISC

	BOLLARD
	11-4-11/16 SPOT ELEVATION

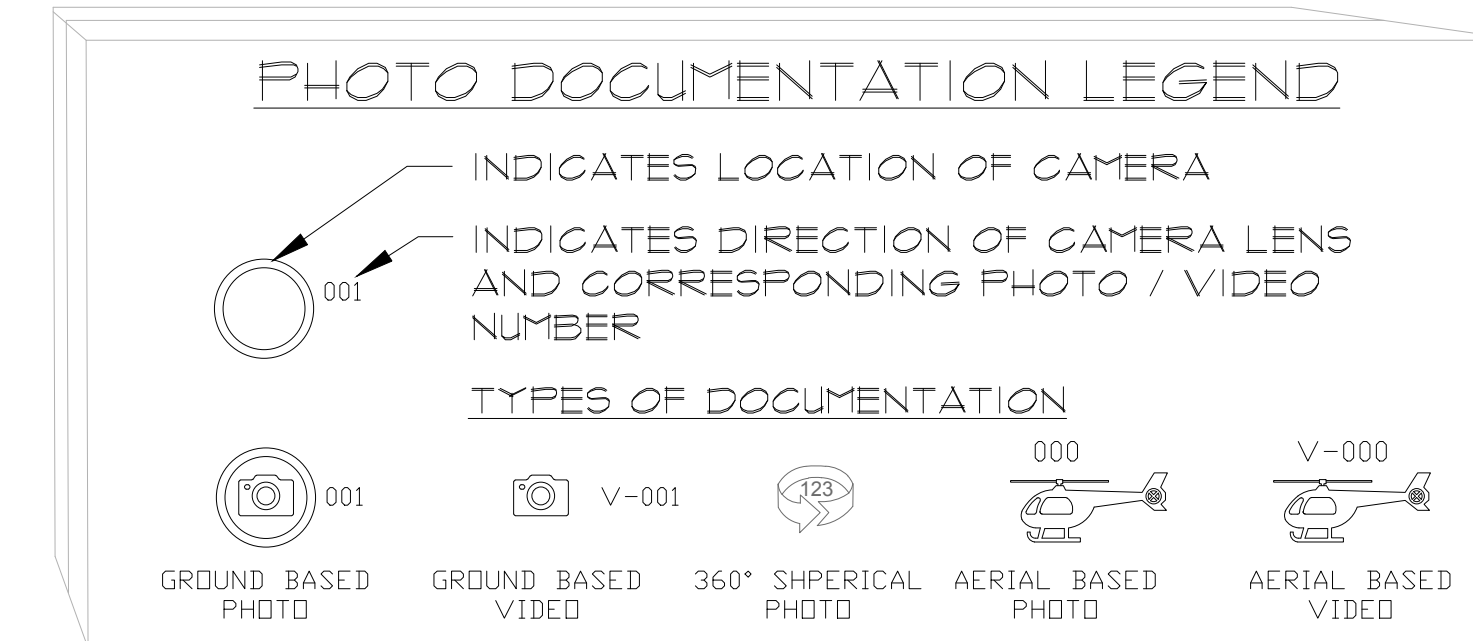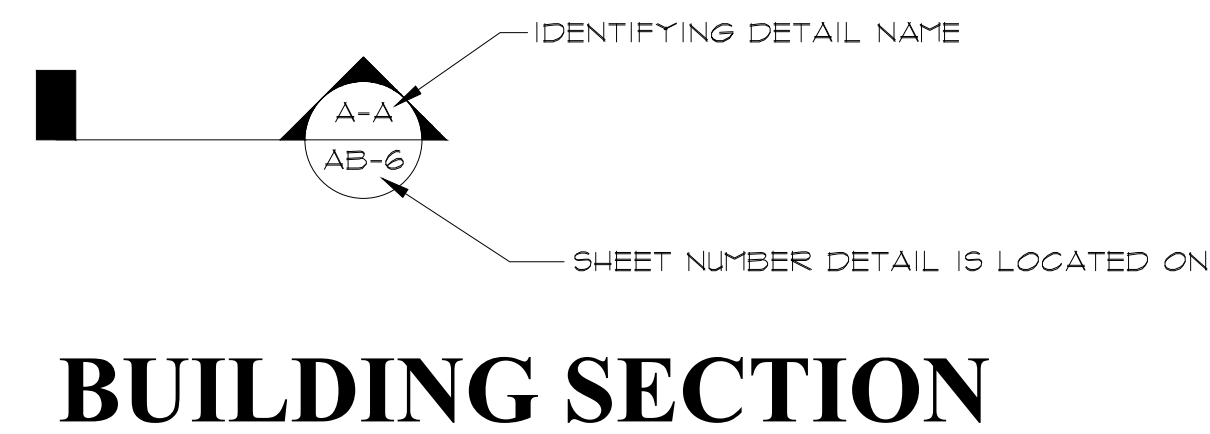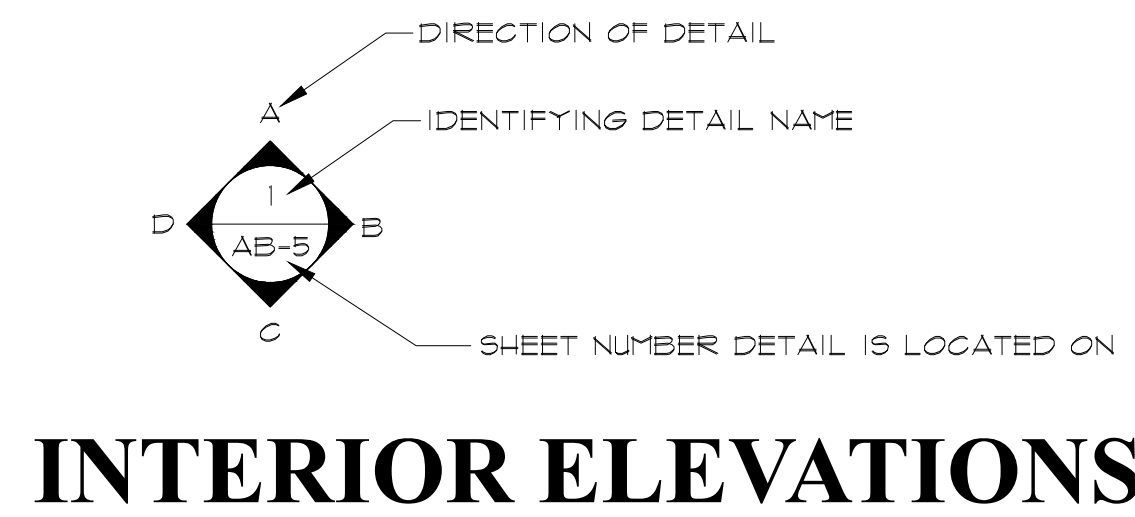


**ARCHITECTURAL AS BUILT**  
**Edgewood Shopping Center**  
**Azusa CA 91702**

01	100% SUBMISSION	SEE COVER SHEET
NO.	ISSUES   REVISIONS	DATE

SHEET TITLE

HL	PROJECT MANAGER
HL	PROJECT DIRECTOR
012317-1	PROJECT NUMBER
NOT TO SCALE	SCALE
CL	DRAWN BY
	SHEET NUMBER

**SL**

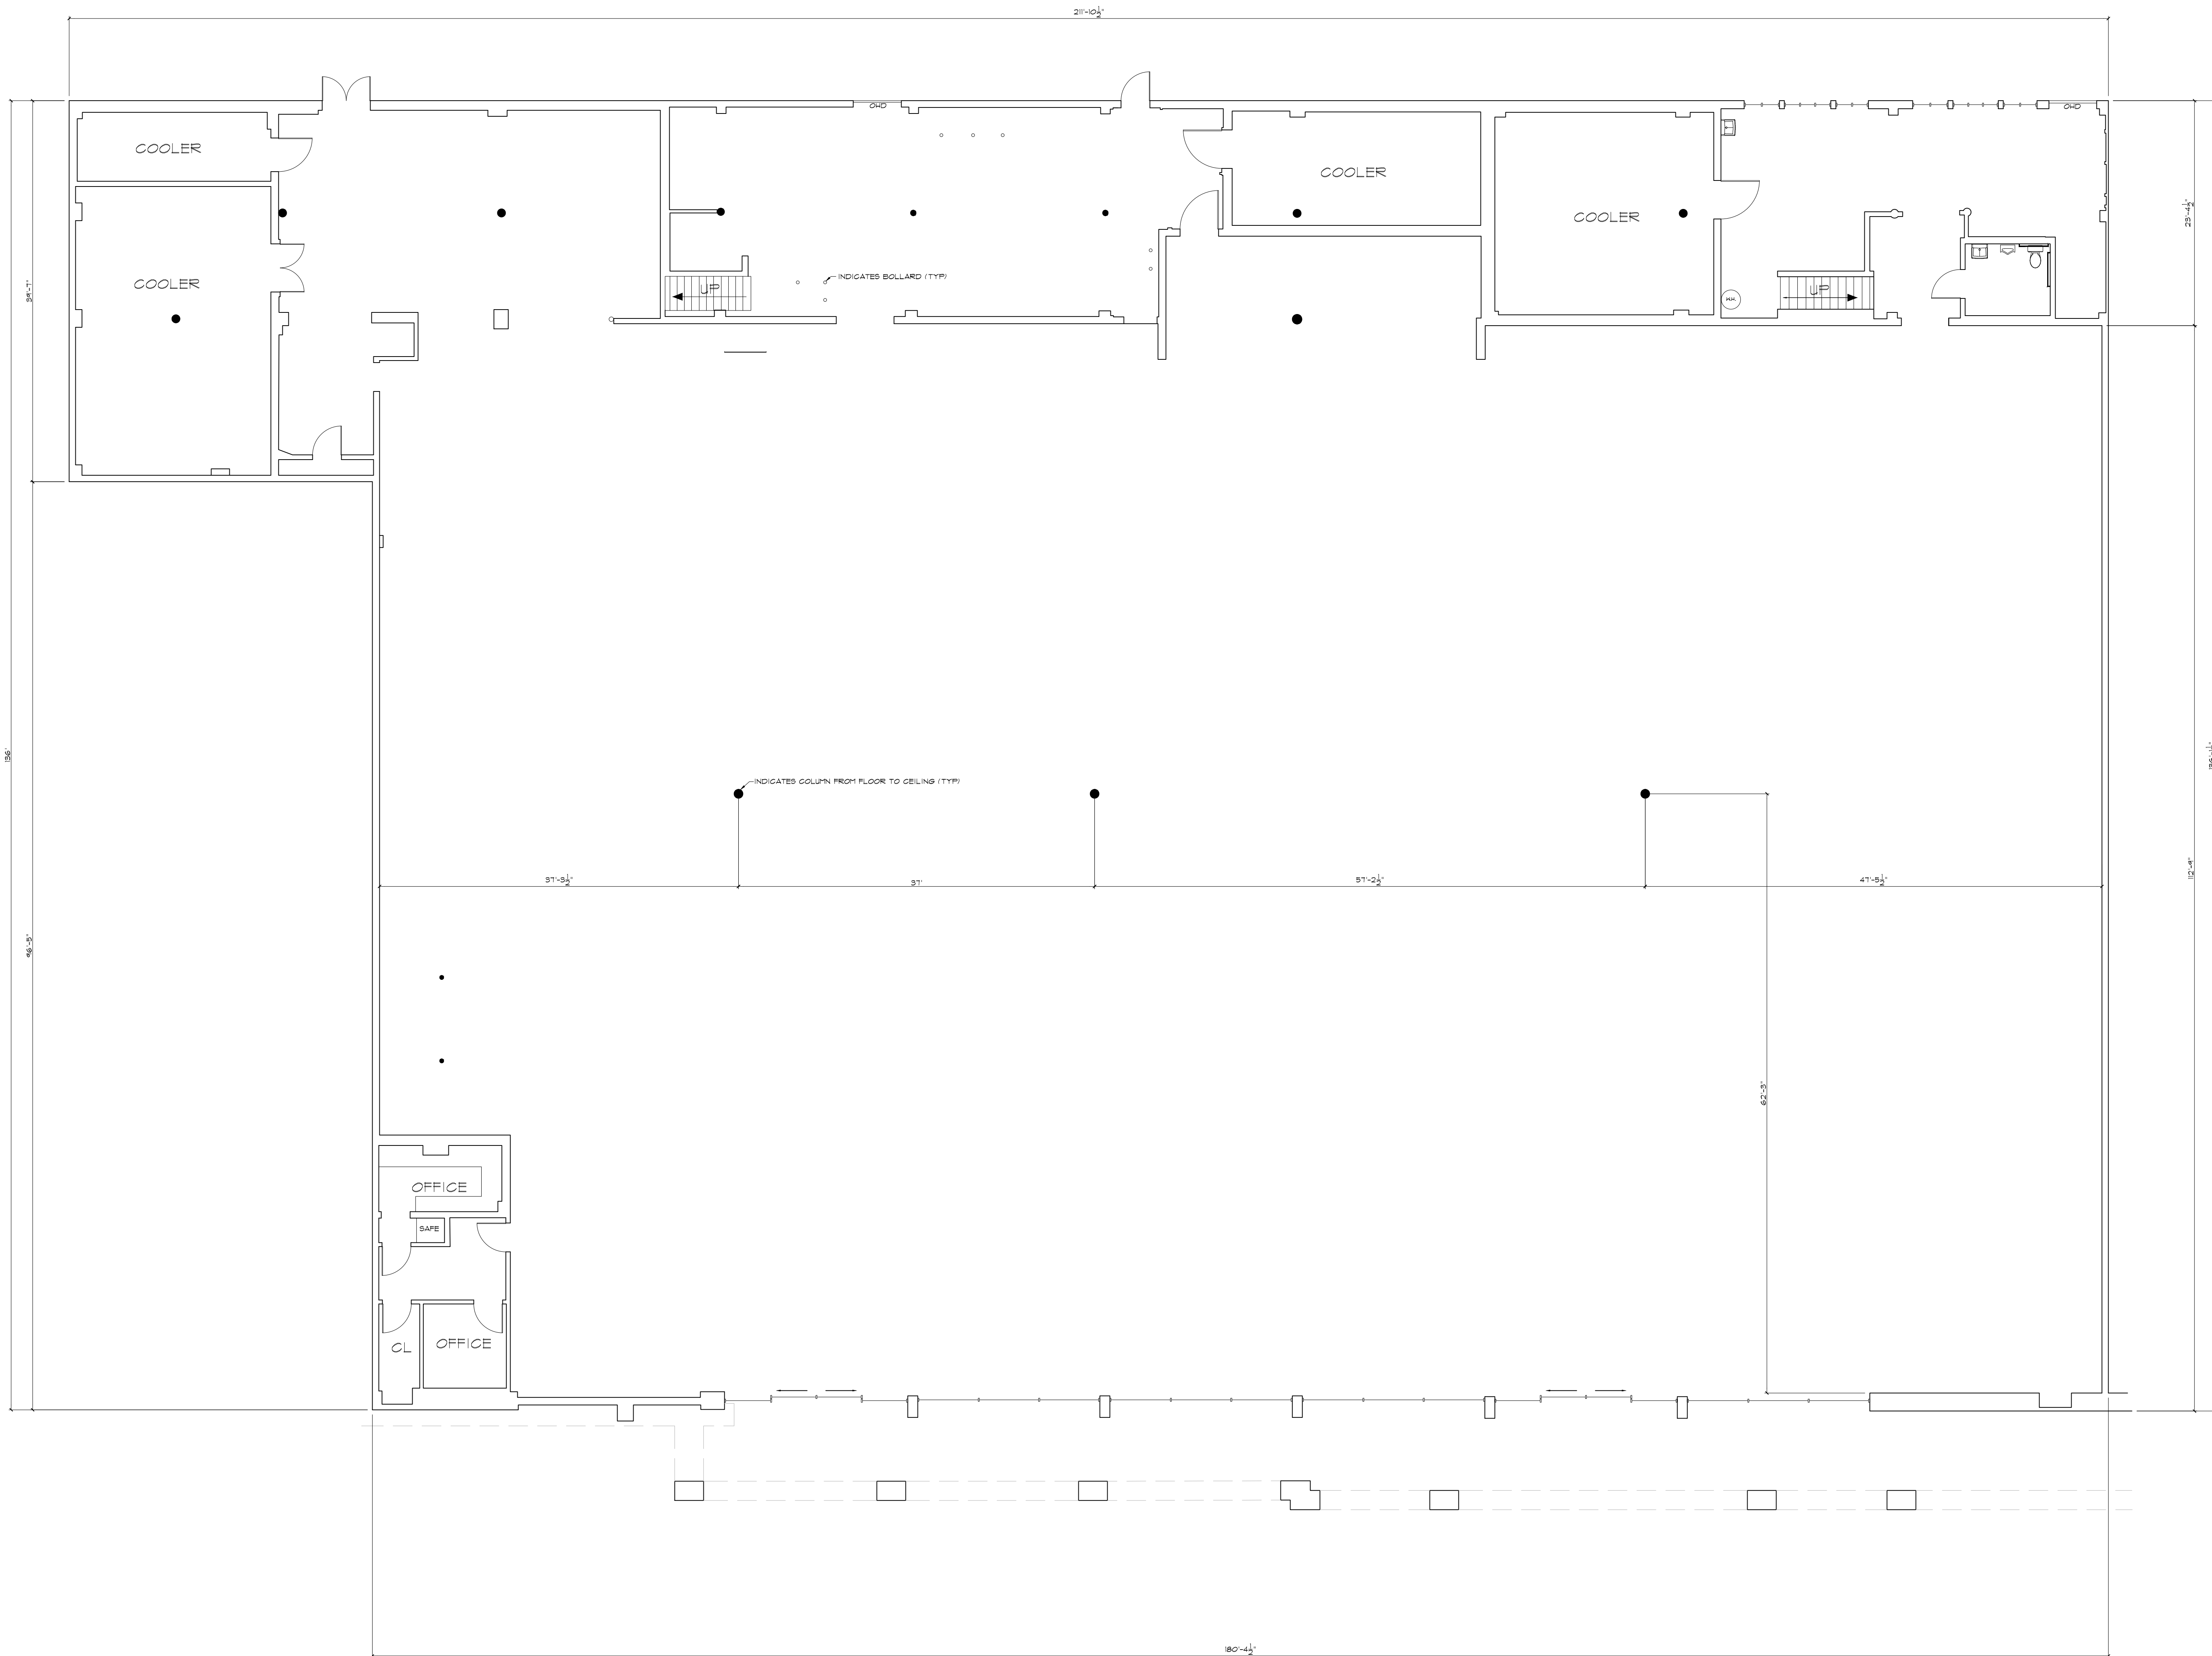


**ARCHITECTURAL AS BUILT**  
**Edgewood Shopping Center**  
 Azusa CA 91702

01	100% SUBMISSION	SEE COVER SHEET
NO.	ISSUES   REVISIONS	DATE
		SHEET TITLE

HL	PROJECT MANAGER
HL	PROJECT DIRECTOR
012317-1	PROJECT NUMBER
1/8"=1'-0"	SCALE
CL	DRAWN BY
	SHEET NUMBER

**AB-1**

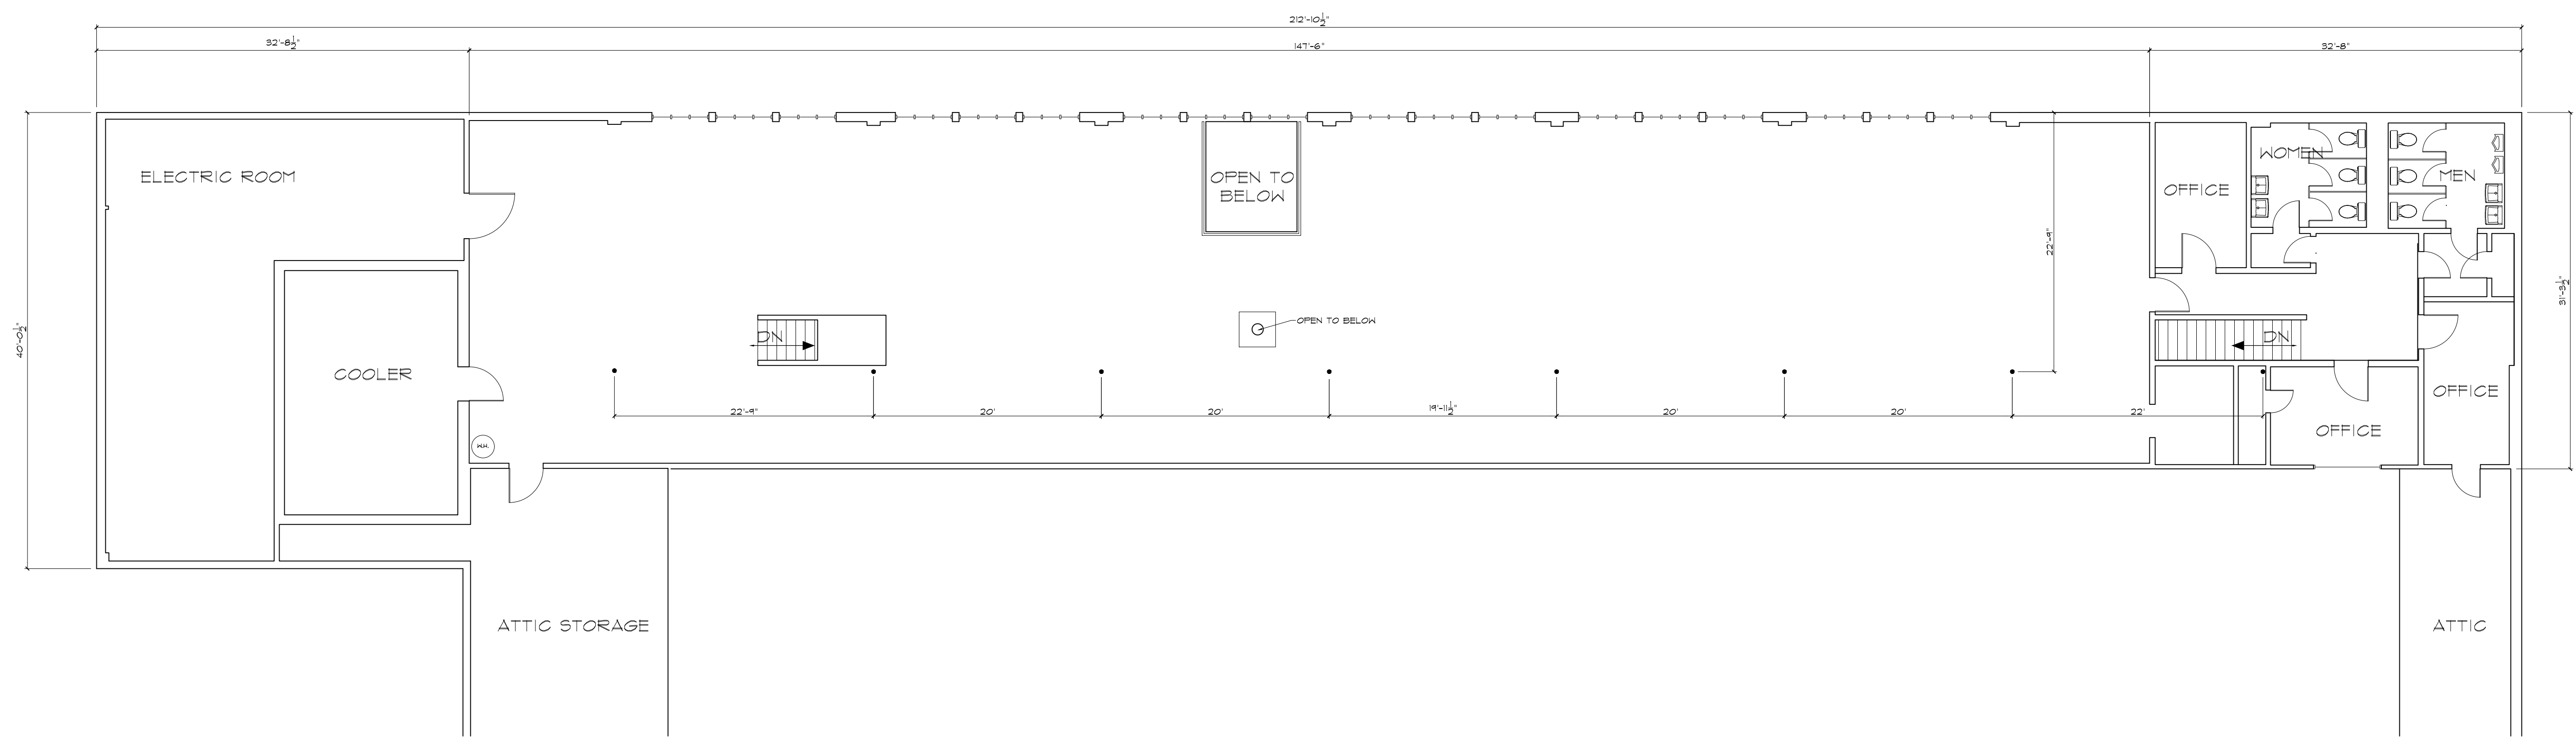

**ARCHITECTURAL AS BUILT**  
**Edgewood Shopping Center**  
 Azusa CA 91702

01	100% SUBMISSION	SEE COVER SHEET
NO.	ISSUES   REVISIONS	DATE

HL	PROJECT MANAGER
HL	PROJECT DIRECTOR
012317-1	PROJECT NUMBER
1/8"=1'-0"	SCALE
CL	DRAWN BY
	SHEET NUMBER

**AB-2**