


AS-BUILT DOCUMENTATION

Skyland Shopping Center



DRAWING INDEX

- C-1 COVER SHEET | DRAWING INDEX
- SL SYMBOLS LEGEND
- AB-1 FLOOR PLAN (MAIN BUILDING OVERALL LAYOUT $\frac{1}{16}"=1'-0"$)
- AB-2 FLOOR PLAN (OUT PARCEL $\frac{1}{4}"=1'-0"$)
- AB-3 FLOOR PLAN (MAIN BUILDING AREA A $\frac{1}{8}"=1'-0"$)
- AB-4 FLOOR PLAN (MAIN BUILDING AREA B $\frac{1}{8}"=1'-0"$)

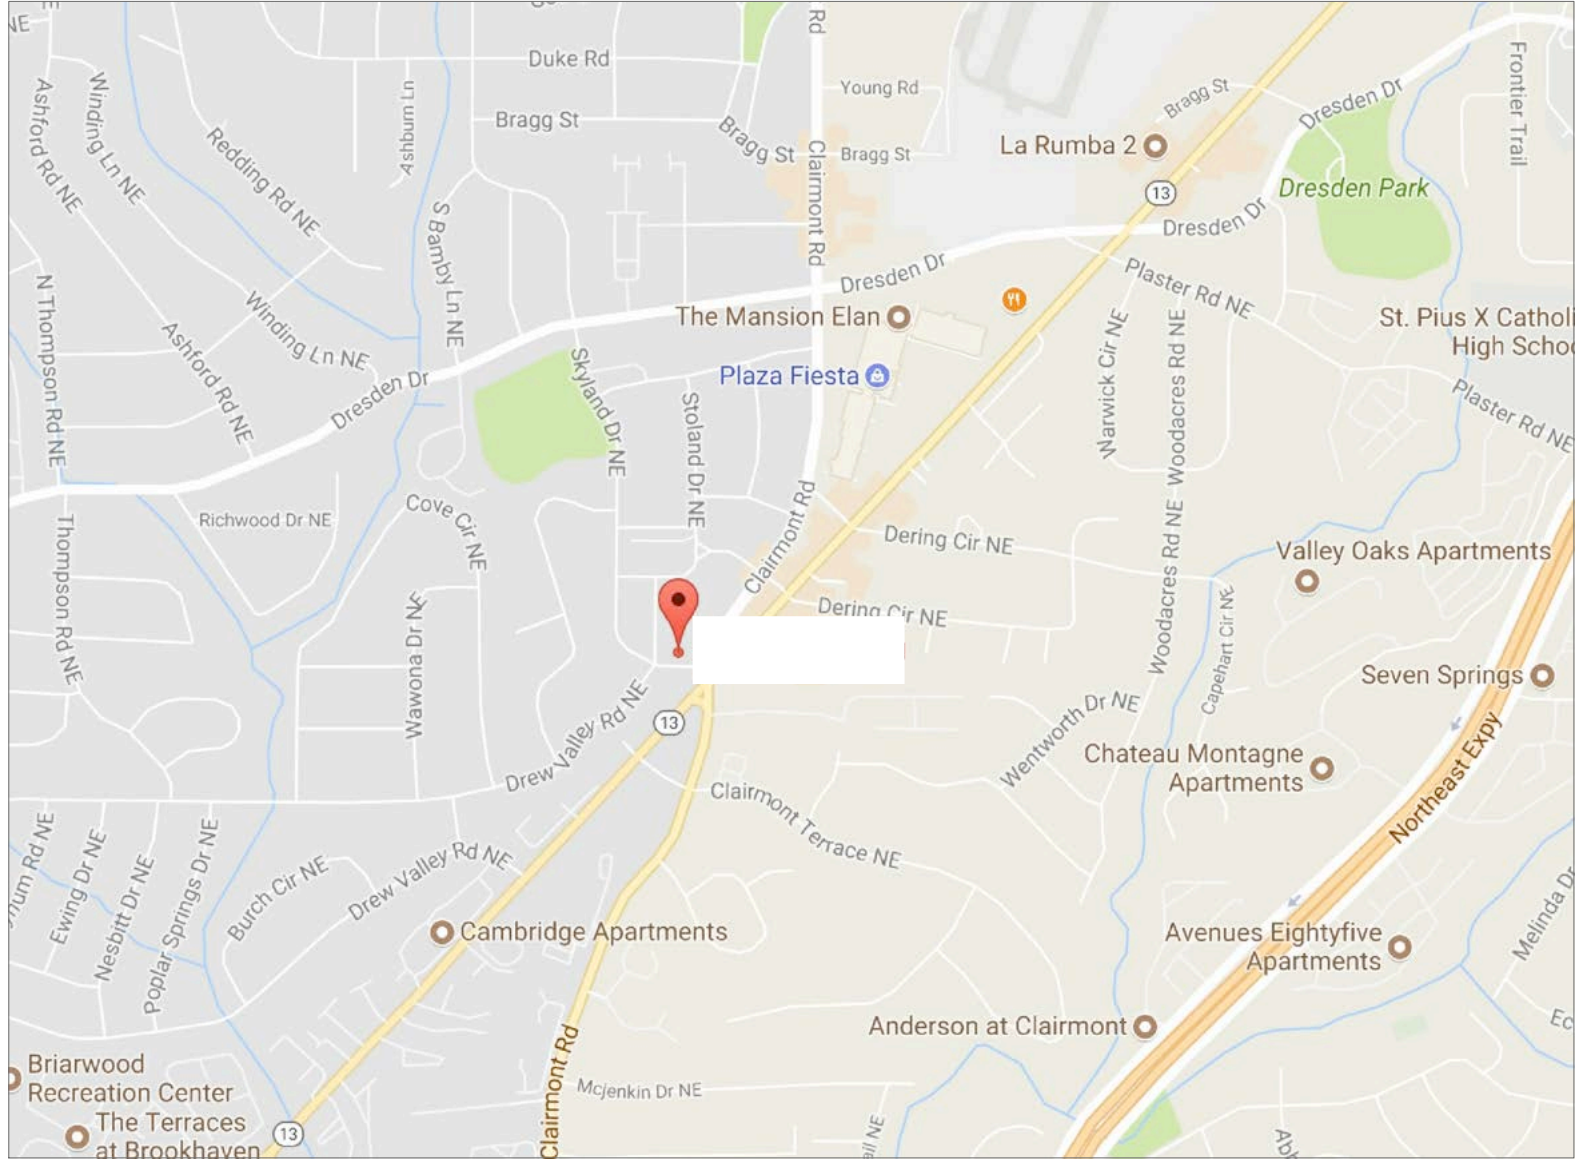

VICINITY MAP
NTS

AS BUILT PROFESSIONALS
www.asbuiltprofessionals.com
A DIVISION OF:



© 2017 AEC CONSULTANTS INC

ARCHITECTURAL AS BUILT
Skyland Shopping Center
Brookhaven GA, 30319

01	100% SUBMISSION	
NO.	ISSUES REVISIONS	DATE

COVER SHEET

HL	PROJECT MANAGER
HL	PROJECT DIRECTOR
012317-1	PROJECT NUMBER
	SCALE
CL	DRAWN BY
	SHEET NUMBER

C-1

100% SUBMITTAL

SYMBOLS LEGEND

RCP

	EXHAUST VENT		TRACK LIGHT OR VANITY LIGHT
	CEILING MOUNTED LIGHT FIXTURE		WALL-MOUNTED LIGHT FIXTURE
	CEILING MOUNTED DIRECTIONAL LIGHT		EMERGENCY EXIT SIGN
	RECESSED CAN LIGHT		EMERGENCY EXIT LIGHT
	EYEBALL OR SMALL CAN LIGHT		EMERGENCY EXIT LIGHT W/ SIGN
	PENDANT LIGHT		LIGHTED STAIR SIGN
	INDIVIDUAL FLUOR. LAY-IN FIXTURE 4 BULB		FLOOD LIGHT
	INDIVIDUAL FLUOR. HANGING FIXTURE 2 BULB		PHOTO CELL
	INDIVIDUAL FLUOR. FLUSH MOUNT FIXTURE 4 BULB		CEILING FAN
	CAMERA		CEILING FAN W/ LIGHT KIT
	MOTION DET.	7-2-6	CEILING HEIGHT AND TRIM 7'-2" ABOVE FLOOR BELOW WITH 6" CROWN MOULDING. NOTE: ALL CEILINGS NOT LABELED ARE PLASTER. CEILINGS SHOWN WITH A GRID ARE LAY IN ACOUSTICAL TILE..
	SUPPLY VENT		JUNCTION BOX
	SUPPLY VENT		
	RETURN VENT		
	RETURN VENT		
	SPEAKER		

ELECTRIC

	DATA OUTLET
	TELEPHONE JACK
	ELECTRIC SWITCH
	CABLE TELEVISION OUTLET
	DUPLEX RECEPTACLE OUTLET
	SPECIAL PURPOSE CONNECTION OR OUTLET
	QUADRUPLEX RECEPTACLE OUTLET
	FLOOR DUPLEX RECEPTACLE OUTLET
	ELECTRIC PANEL
	ELECTRIC METER
	BUTTON SWITCH
	DISCONNECT SWITCH
	GROUND/FLOOR LIGHT
	KEY PAD

FIRE PROTECTION

	FIRE EXTINGUISHER
	FIRE PULL
	FIRE ALARM (HORN/SRTOBE)
	SMOKE DETECTOR
	SMOKE ALARM SPEAKER
	SPRINKLER HEAD CEILING MOUNT
	SPRINKLER HEAD WALL MOUNT

MEP

	THERMOSTAT
	FLOOR DRAIN
	VALVE
	HOSE BIB
	WATER SUPPLY
	SUSPENDED GAS HEATER

MISC

	BOLLARD
--	---------

7-2-6 CEILING HEIGHT AND TRIM 7'-2" ABOVE FLOOR BELOW WITH 6" CROWN MOULDING. NOTE: ALL CEILINGS NOT LABELED ARE PLASTER. CEILINGS SHOWN WITH A GRID ARE LAY IN ACOUSTICAL TILE..

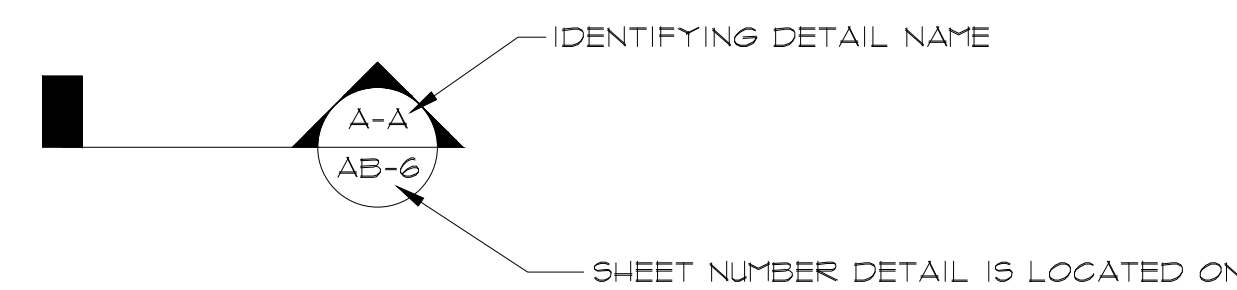
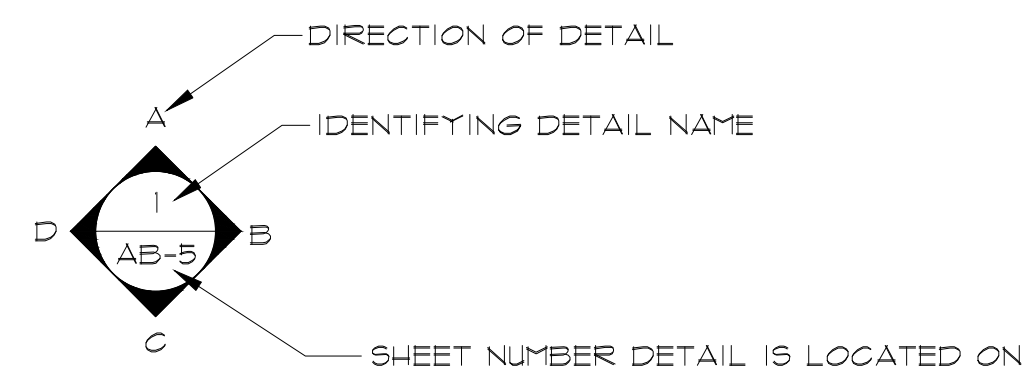


PHOTO DOCUMENTATION LEGEND

INDICATES LOCATION OF CAMERA

INDICATES DIRECTION OF CAMERA LENS AND CORRESPONDING PHOTO / VIDEO NUMBER

TYPES OF DOCUMENTATION

GROUND BASED PHOTO	GROUND BASED VIDEO	360° SPHERICAL PHOTO	AERIAL BASED PHOTO	AERIAL BASED VIDEO

AS BUILT PROFESSIONALS
www.asbuiltprofessionals.com
A DIVISION OF:

AEC CONSULTANTS INC


844.272.8458
844 AS BUILT

© 2011 AEC CONSULTANTS INC

ARCHITECTURAL AS BUILT
Skyland Shopping Center
Brookhaven GA, 30319

01	100% SUBMISSION	
NO.	ISSUES REVISIONS	DATE
SHEET TITLE		
HL	PROJECT MANAGER	
HL	PROJECT DIRECTOR	
012317-1	PROJECT NUMBER	
NOT TO SCALE	SCALE	
CL	DRAWN BY	
	SHEET NUMBER	

SL

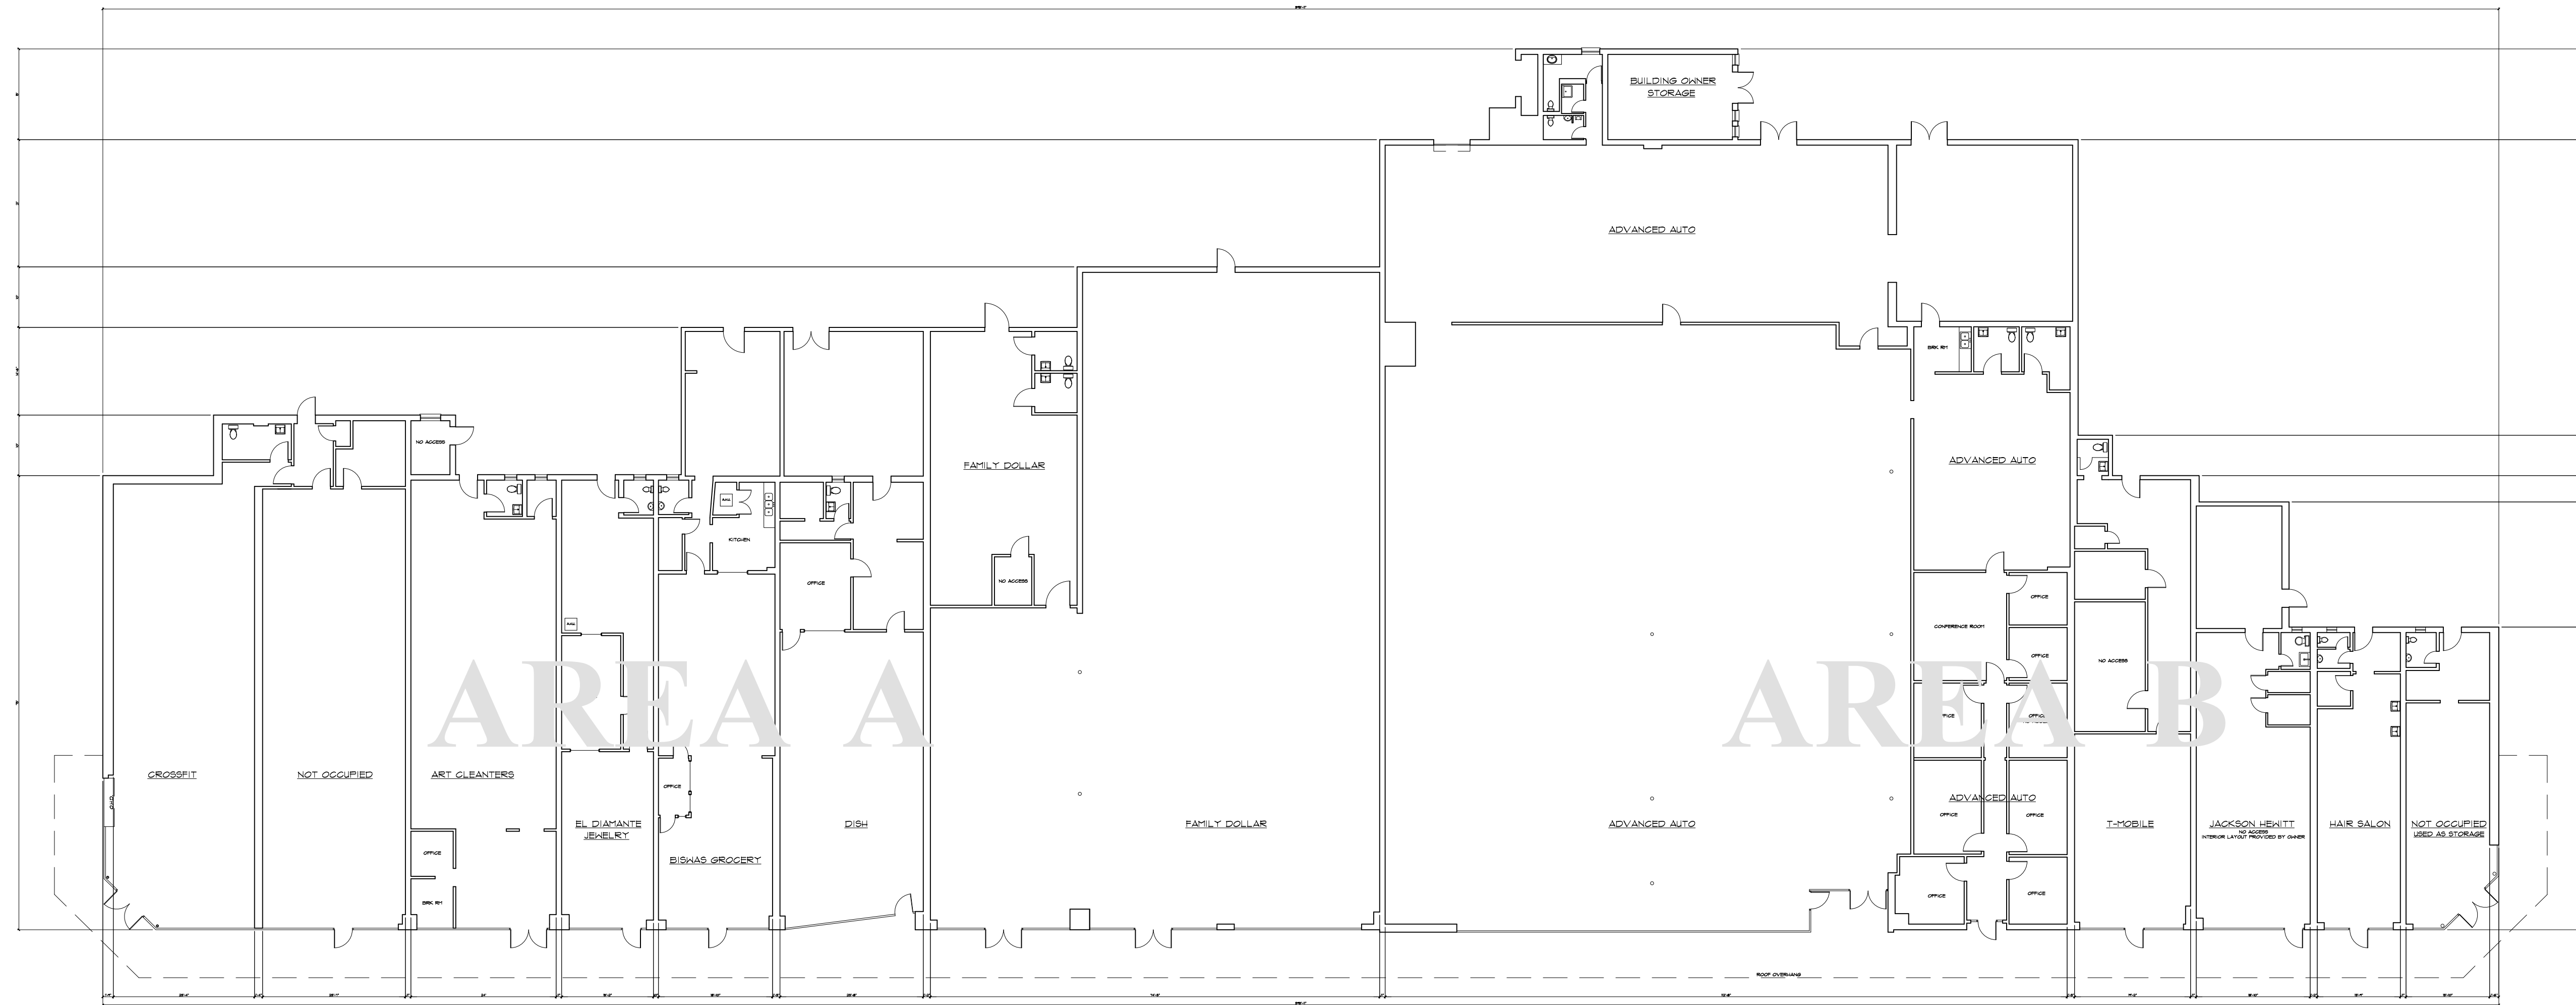

FLOOR PLAN


ARCHITECTURAL AS BUILT
Skyland Shopping Center
 Brookhaven GA, 30319

NO.	ISSUES REVISIONS	DATE
01	100% SUBMISSION	

FLOOR PLAN
MAIN BUILDING
OVERALL LAYOUT

HL	PROJECT MANAGER
HL	PROJECT DIRECTOR
012317-1	PROJECT NUMBER
1/16"=1'-0"	SCALE
CL	DRAWN BY
	SHEET NUMBER

 AB-1



FLOOR PLAN

ARCHITECTURAL AS BUILT
Skyland Shopping Center
 Brookhaven GA, 30319

NO.	ISSUES REVISIONS	DATE
01	100% SUBMISSION	

FLOOR PLAN
OUT PARCEL

HL	PROJECT MANAGER
HL	PROJECT DIRECTOR
012317-1	PROJECT NUMBER
1/4"=1'-0"	SCALE
CL	DRAWN BY
	SHEET NUMBER

AB-2




ARCHITECTURAL AS BUILT
Skyland Shopping Center
Brookhaven GA, 30319

NO.	ISSUES REVISIONS	DATE

01 100% SUBMISSION
NO. ISSUES | REVISIONS DATE

SHEET TITLE	
FLOOR PLAN MAIN BUILDING AREA A 1/8" SCALE	
HL	PROJECT MANAGER
HL	PROJECT DIRECTOR
012317-1	PROJECT NUMBER
1/8"=1'-0"	SCALE
CL	DRAWN BY
	SHEET NUMBER

FLOOR PLAN

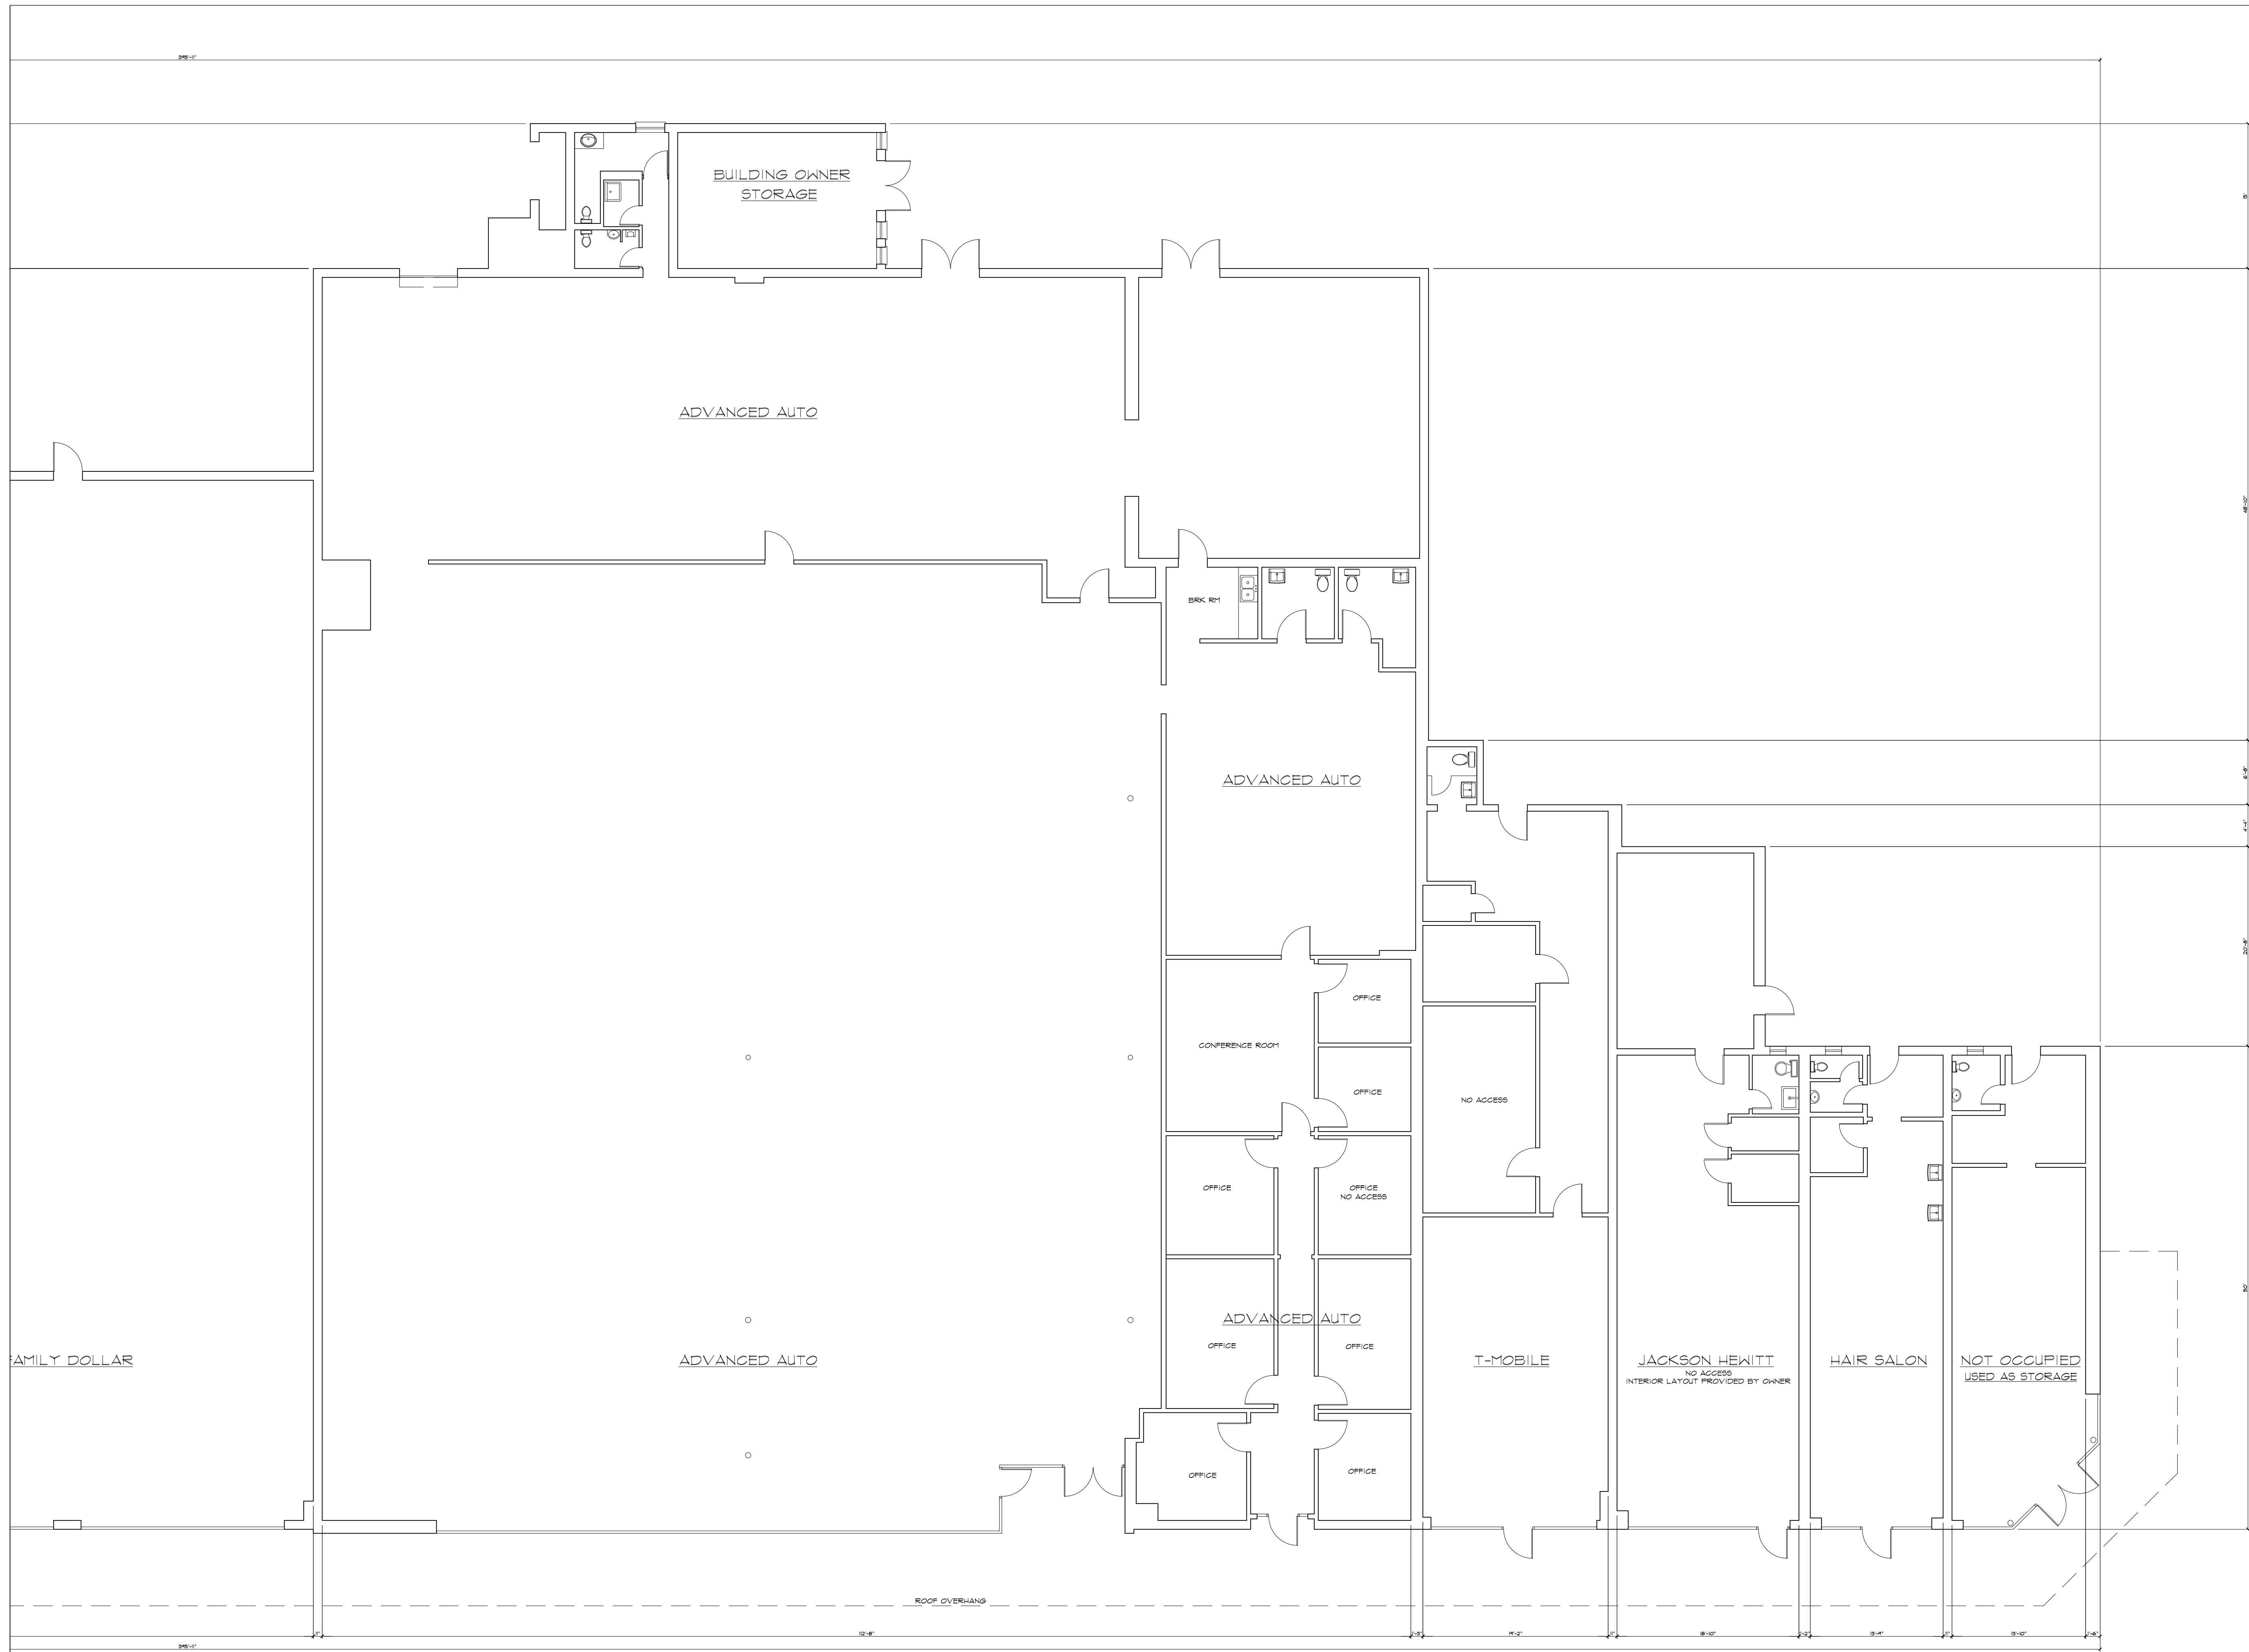

FLOOR PLAN

ARCHITECTURAL AS BUILT
Skyland Shopping Center
 Brookhaven GA, 30319

NO.	ISSUES REVISIONS	DATE
01	100% SUBMISSION	

FLOOR PLAN
MAIN BUILDING
AREA B
1/8" SCALE

HL	PROJECT MANAGER
HL	PROJECT DIRECTOR
012317-1	PROJECT NUMBER
1/8"=1'-0"	SCALE
CL	DRAWN BY
	SHEET NUMBER

AB-4