
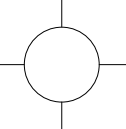
 
 
 

 
 
 


 


 

 
 

 
 

 

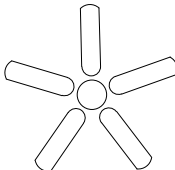
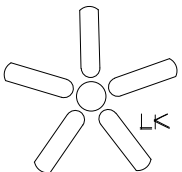



SYMBOLS LEGEND


 




 
 
 
 




RCP

-  EXHAUST VENT
-  CEILING MOUNTED LIGHT FIXTURE
-  CEILING MOUNTED DIRECTIONAL LIGHT
-  RECESSED CAN LIGHT
-  EYEBALL OR SMALL CAN LIGHT
-  PENDANT LIGHT
-  INDIVIDUAL FLUOR. LAY-IN FIXTURE 4 BULB
-  INDIVIDUAL FLUOR. HANGING FIXTURE 2 BULB
-  INDIVIDUAL FLUOR. FLUSH MOUNT FIXTURE 4 BULB
-  CAMERA
-  MOTION DET.
-  SUPPLY VENT
-  SUPPLY VENT
-  RETURN VENT
-  RETURN VENT
-  SPEAKER







 
-  TRACK LIGHT OR VANITY LIGHT
-  WALL-MOUNTED LIGHT FIXTURE
-  EMERGENCY EXIT SIGN
-  EMERGENCY EXIT LIGHT
-  EMERGENCY EXIT LIGHT W/ SIGN
-  LIGHTED STAIR SIGN
-  FLOOD LIGHT
-  PHOTO CELL
-  CEILING FAN
-  CEILING FAN W/ LIGHT KIT
-  JUNCTION BOX

7-2-6 CEILING HEIGHT AND TRIM 7'-2" ABOVE FLOOR BELOW WITH 6" CROWN MOULDING. NOTE: ALL CEILINGS NOT LABELED ARE PLASTER. CEILINGS SHOWN WITH A GRID ARE LAY IN ACOUSTICAL TILE..







ELECTRIC

-  DATA OUTLET
-  TELEPHONE JACK
-  ELECTRIC SWITCH
-  CABLE TELEVISION OUTLET
-  DUPLEX RECEPTACLE OUTLET
-  SPECIAL PURPOSE CONNECTION OR OUTLET
-  QUADRUPLEX RECEPTACLE OUTLET
-  FLOOR DUPLEX RECEPTACLE OUTLET
-  ELECTRIC PANEL
-  ELECTRIC METER
-  BUTTON SWITCH
-  DISCONNECT SWITCH
-  GROUND/FLOOR LIGHT
-  KEY PAD

FIRE PROTECTION

-  FIRE EXTINGUISHER
-  FIRE PULL
-  FIRE ALARM (HORN/SRTOBE)
-  SMOKE DETECTOR
-  SMOKE ALARM SPEAKER
-  SPRINKLER HEAD CEILING MOUNT
-  SPRINKLER HEAD WALL MOUNT

MEP

-  THERMOSTAT
-  FLOOR DRAIN
-  VALVE
-  HOSE BIB
-  WATER SUPPLY
-  SUSPENDED GAS HEATER

MISC

-  BOLLARD

7-2-6

CEILING HEIGHT AND TRIM 7'-2" ABOVE FLOOR BELOW WITH 6" CROWN MOULDING. NOTE: ALL CEILINGS NOT LABELED ARE PLASTER. CEILINGS SHOWN WITH A GRID ARE LAY IN ACOUSTICAL TILE..

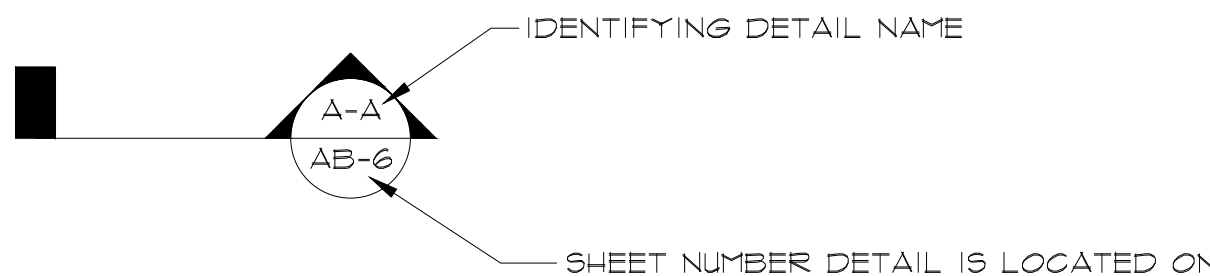
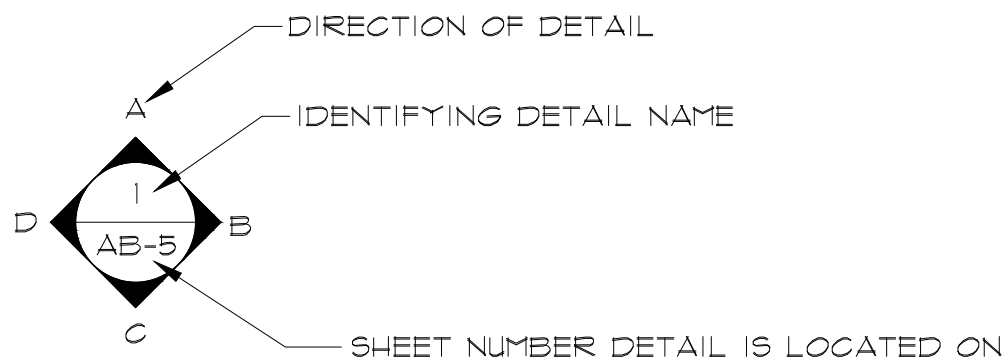




PHOTO DOCUMENTATION LEGEND

-  INDICATES LOCATION OF CAMERA
-  INDICATES DIRECTION OF CAMERA LENS AND CORRESPONDING PHOTO / VIDEO NUMBER

TYPES OF DOCUMENTATION

-  001 GROUND BASED PHOTO
-  V-001 GROUND BASED VIDEO
-  023 360° SPHERICAL PHOTO
-  001 AERIAL BASED PHOTO
-  V-001 AERIAL BASED VIDEO

AS BUILT
PROFESSIONALS

A DIVISION OF:



© 2011 AEC CONSULTANTS INC

ARCHITECTURAL AS BUILT
Squaw Valley Members Locker Room
Olympic Valley CA, 96146

01 100% SUBMISSION
NO. ISSUES | REVISIONS

DATE

SHEET TITLE

HL PROJECT MANAGER

HL PROJECT DIRECTOR


012317-1 PROJECT NUMBER

NOT TO SCALE SCALE

CL DRAWN BY

SHEET NUMBER

SL

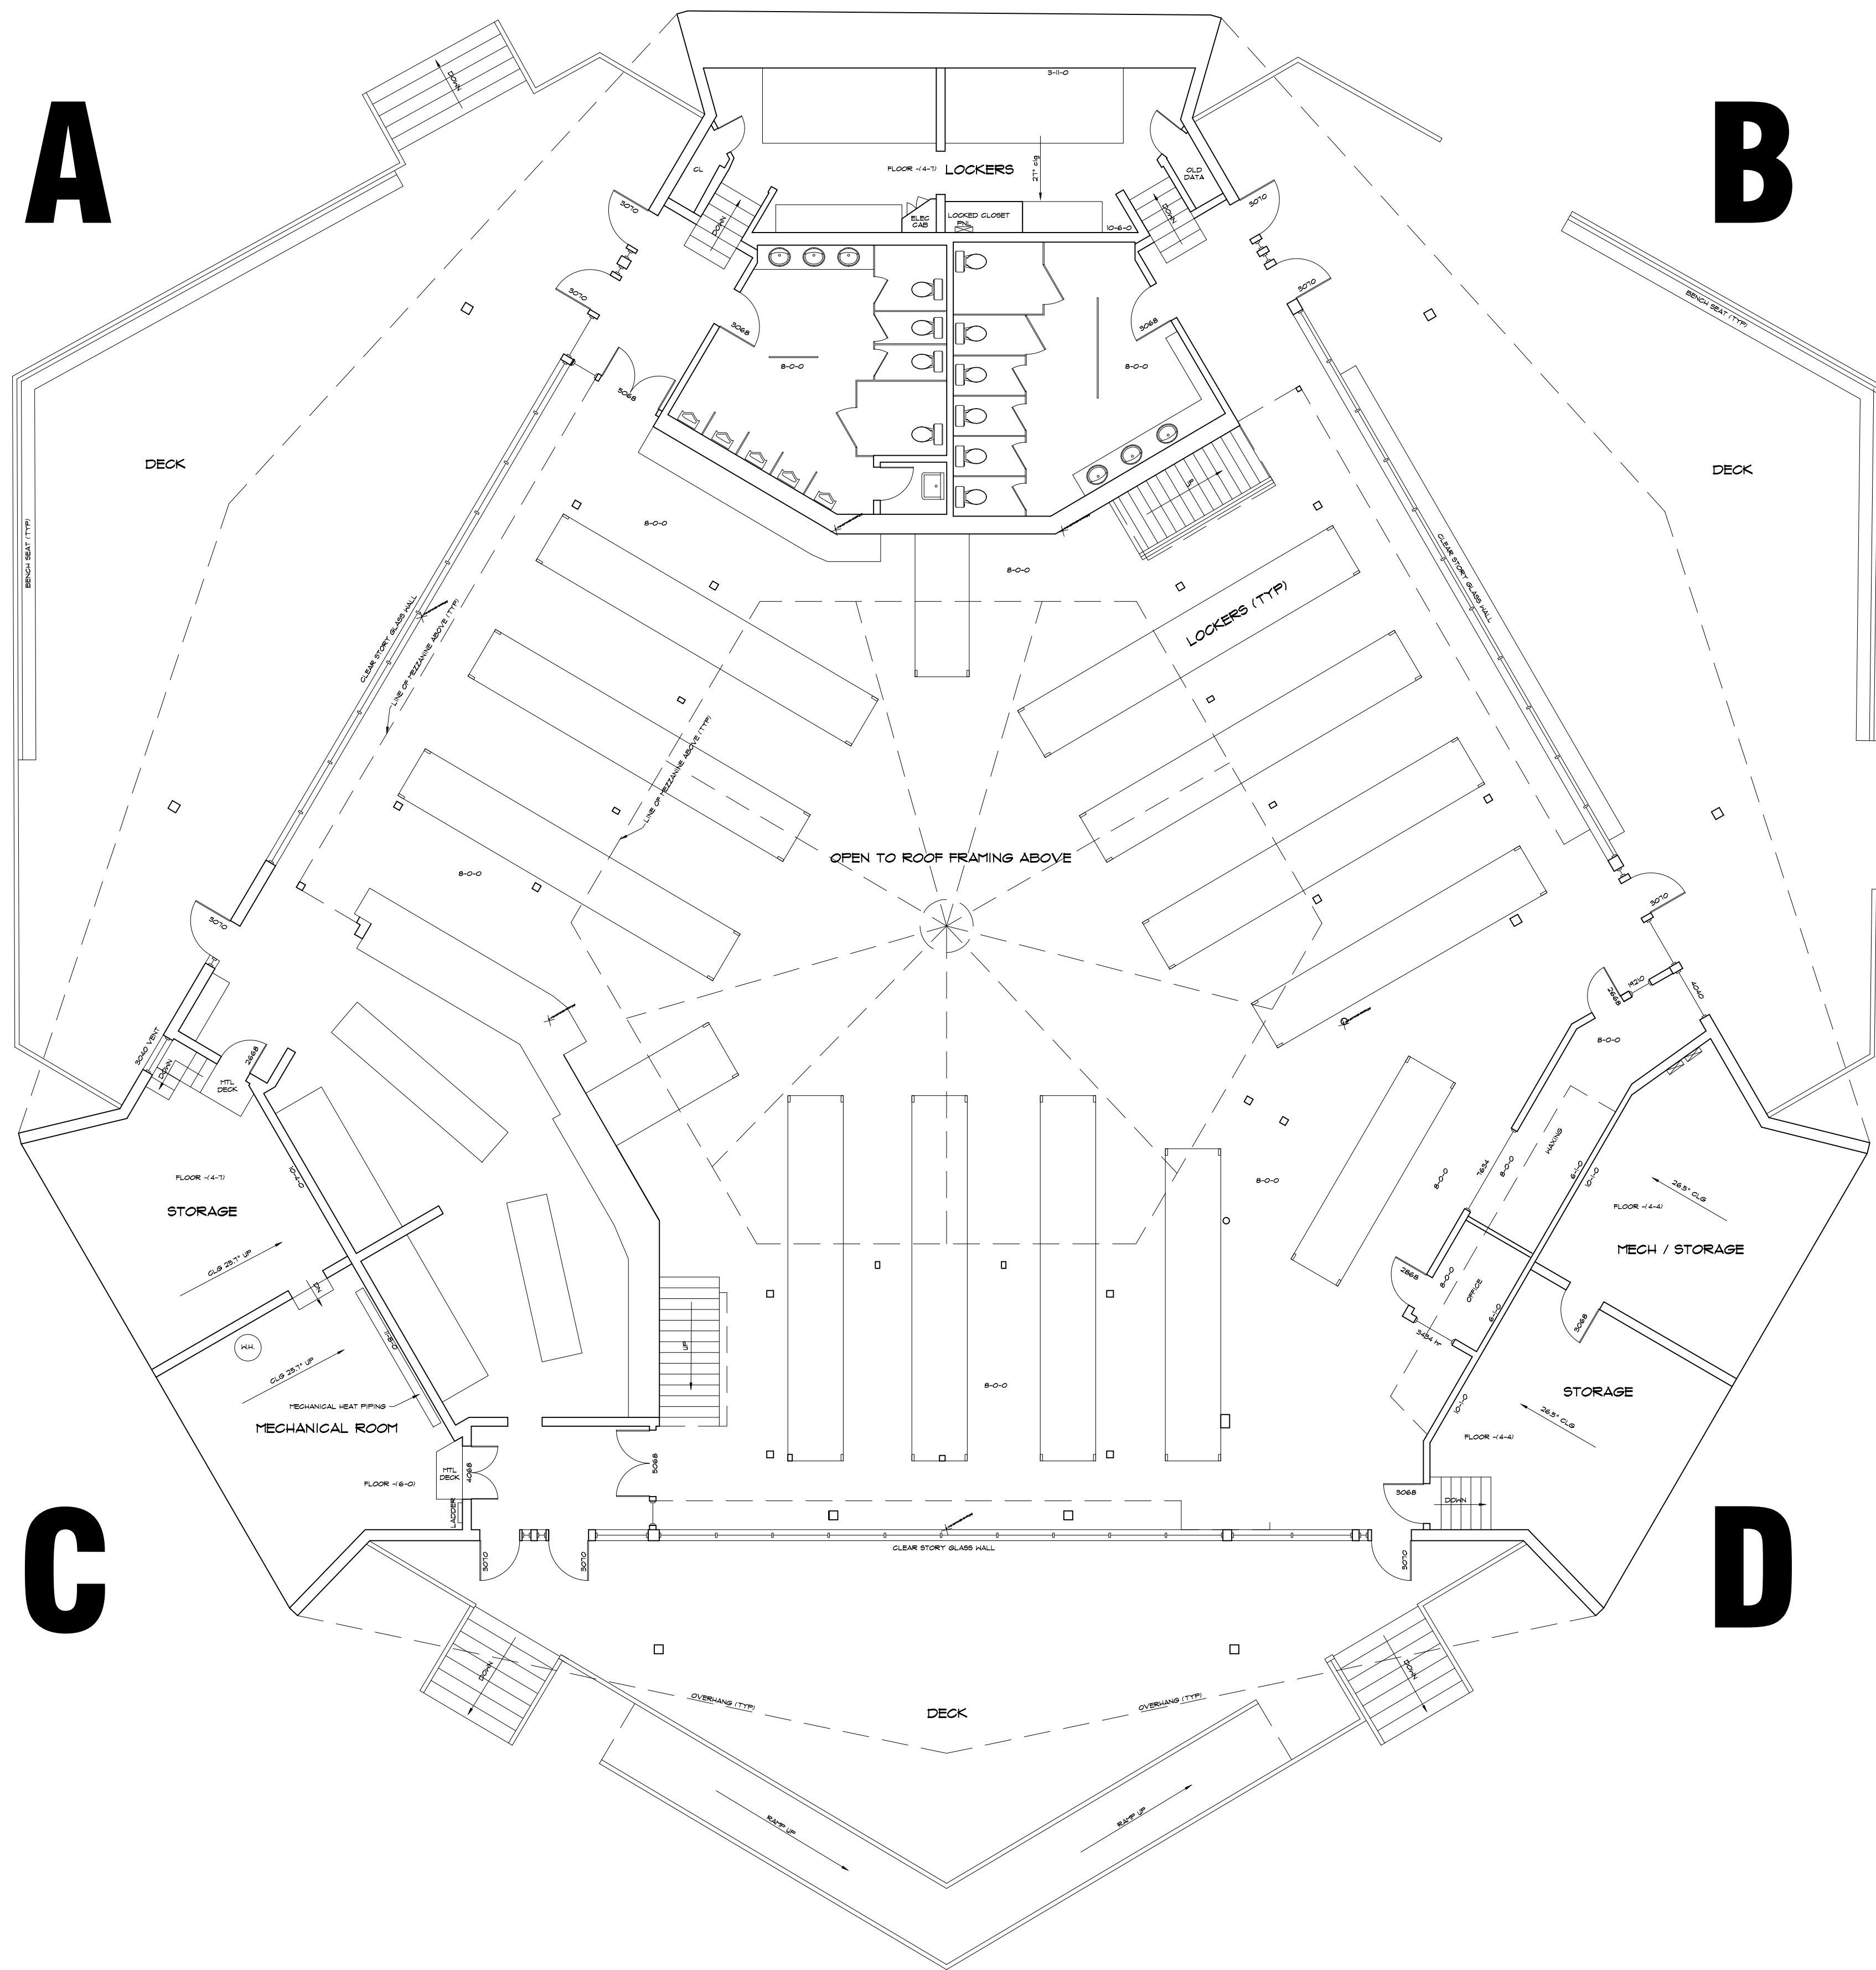

FIRST FLOOR PLAN

As BUILT
PROFESSIONALS
A DIVISION OF:

AEC
CONSULTANTS INC
www.aecconsultantsinc.com
844.272.8458

© 2011 AEC CONSULTANTS INC

ARCHITECTURAL AS BUILT
Squaw Valley Members Locker Room
Olympic Valley CA, 96146

01	100% SUBMISSION	
NO.	ISSUES REVISIONS	DATE
SHEET TITLE		
HL	PROJECT MANAGER	
HL	PROJECT DIRECTOR	
012317-1	PROJECT NUMBER	
1/8"=1'-0"	SCALE	
CL	DRAWN BY	
SHEET NUMBER		

AB-1

AREA A



A DIVISION OF:




© 2017 AEC CONSULTANTS INC

ARCHITECTURAL AS BUILT
Squaw Valley Members Locker Room
Olympic Valley CA, 96146

01	100% SUBMISSION	
NO.	ISSUES REVISIONS	DATE
		SHEET TITLE
HL		PROJECT MANAGER
HL		PROJECT DIRECTOR
012317-1		PROJECT NUMBER
1/4"=1'-0"		SCALE
CL		DRAWN BY
		SHEET NUMBER

AB-2

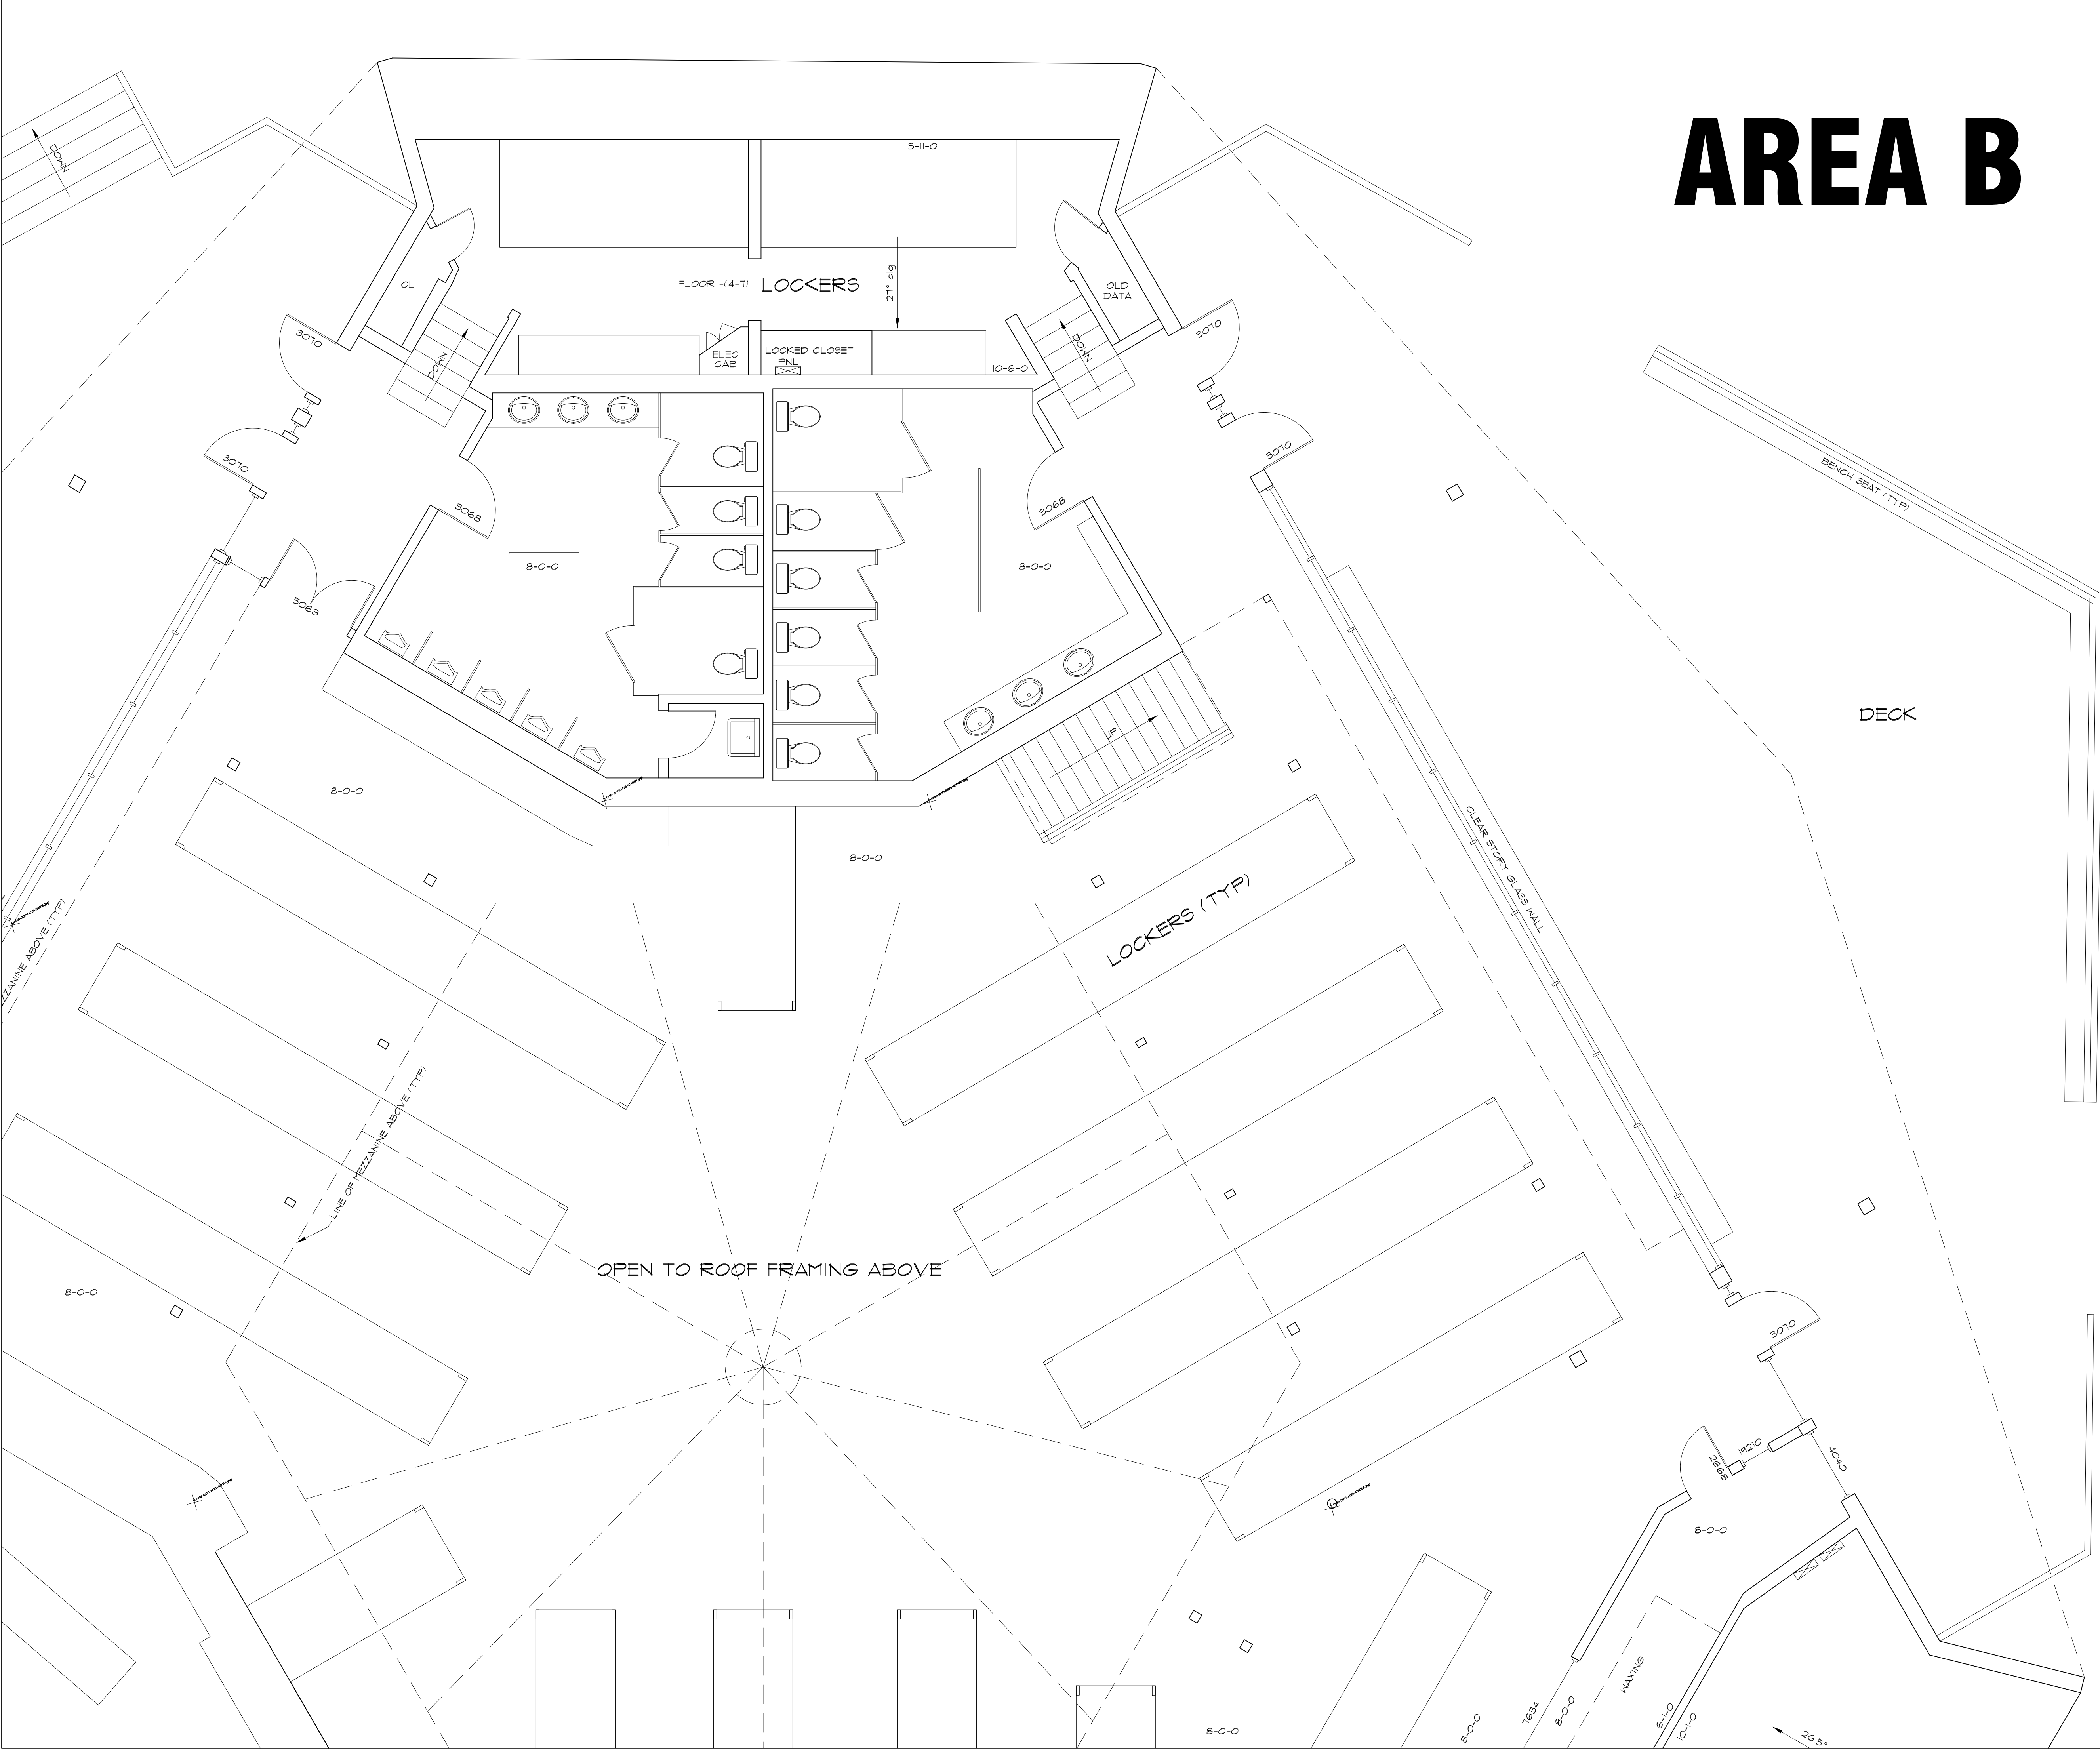

AREA B

As BUILT
PROFESSIONALS

A DIVISION OF:

AEC

CONSULTANTS INC

www.aecconsultantsinc.com

844.272.8458

© 2011 AEC CONSULTANTS INC

ARCHITECTURAL AS BUILT
Squaw Valley Members Locker Room
Olympic Valley CA, 96146

01	100% SUBMISSION	
NO.	ISSUES REVISIONS	DATE
		SHEET TITLE
HL		PROJECT MANAGER
HL		PROJECT DIRECTOR
012317-1		PROJECT NUMBER
1/4"=1'-0"		SCALE
CL		DRAWN BY
		SHEET NUMBER

 
AB-3



Olympic Valley CA, 96146

AB-4

AB-4



AREA D

 


ARCHITECTURAL AS BUILT
Squaw Valley Members Locker Room
Olympic Valley CA, 96146

AB-5



Olympic Valley CA, 96146



AB-6