

 
Time Square Business Park

South Salt Lake City, UT 84115



C-1	COVER SHEET DRAWING INDEX
SL	SYMBOLS LEGEND
BL-1	BUILDING LOCATIONS
AB-1	BUILDING 1
AB-2	BUILDING 2
AB-3	BUILDING 3
AB-4	BUILDING 4
AB-5.1	BUILDING 5
AB-5.2	BUILDING 5
AB-6	BUILDING 6
AB-7	BUILDING 7
AB-8	BUILDING 8
AB-9	BUILDING 9
AB-10	BUILDING 10
AB-11	BUILDING 11
AB-12	BUILDING 12



 As BUILT PROFESSIONALS www.asbuiltprofessionals.com A DIVISION OF:  AEC CONSULTANTS INC. 844.272.8458 844 ASBUILT © 2014 AEC CONSULTANTS INC.		
ARCHITECTURAL AS BUILT Time Square Business Park South Salt Lake City, UT 84115		
O1	100% SUBMISSION	SEE COVER SHEET
NO.	ISSUES REVISIONS	DATE
		SHEET TITLE
COVER SHEET		
HL	PROJECT MANAGER	
HL	PROJECT DIRECTOR	
012317-1	PROJECT NUMBER	
	SCALE	
CL	DRAWN BY	
	SHEET NUMBER	
C-1		

SYMBOLS LEGEND

RCP

	EXHAUST VENT		TRACK LIGHT OR VANITY LIGHT
	CEILING MOUNTED LIGHT FIXTURE		WALL-MOUNTED LIGHT FIXTURE
	CEILING MOUNTED DIRECTIONAL LIGHT		EMERGENCY EXIT SIGN
	RECESSED CAN LIGHT		EMERGENCY EXIT LIGHT
	EYEBALL OR SMALL CAN LIGHT		EMERGENCY EXIT LIGHT W/ SIGN
	PENDANT LIGHT		LIGHTED STAIR SIGN
	INDIVIDUAL FLUOR. LAY-IN FIXTURE 4 BULB		FLOOD LIGHT
	INDIVIDUAL FLUOR. HANGING FIXTURE 2 BULB		PHOTO CELL
	INDIVIDUAL FLUOR. FLUSH MOUNT FIXTURE 4 BULB		CEILING FAN
	CAMERA		CEILING FAN W/ LIGHT KIT
	MOTION DET.		7-2-6 CEILING HEIGHT AND TRIM 7'-2" ABOVE FLOOR BELOW WITH 6" CROWN MOULDING. NOTE: ALL CEILINGS NOT LABELED ARE PLASTER. CEILINGS SHOWN WITH A GRID ARE LAY IN ACOUSTICAL TILE..
	SUPPLY VENT		JUNCTION BOX
	SUPPLY VENT		
	RETURN VENT		
	RETURN VENT		
	SPEAKER		

ELECTRIC

	DATA OUTLET
	TELEPHONE JACK
	ELECTRIC SWITCH
	CABLE TELEVISION OUTLET
	DUPLEX RECEPTACLE OUTLET
	SPECIAL PURPOSE CONNECTION OR OUTLET
	QUADRUPLIX RECEPTACLE OUTLET
	FLOOR DUPLEX RECEPTACLE OUTLET
	ELECTRIC PANEL
	ELECTRIC METER
	BUTTON SWITCH
	DISCONNECT SWITCH
	GROUND/FLOOR LIGHT
	KEY PAD

FIRE PROTECTION


	FIRE EXTINGUISHER
	FIRE PULL
	FIRE ALARM (HORN/SRTOBE)
	SMOKE DETECTOR
	SMOKE ALARM SPEAKER
	SPRINKLER HEAD CEILING MOUNT
	SPRINKLER HEAD WALL MOUNT

MEP


	THERMOSTAT
	FLOOR DRAIN
	VALVE
	HOSE BIB
	WATER SUPPLY
	SUSPENDED GAS HEATER

MISC


	BOLLARD
	SPOT ELEVATION

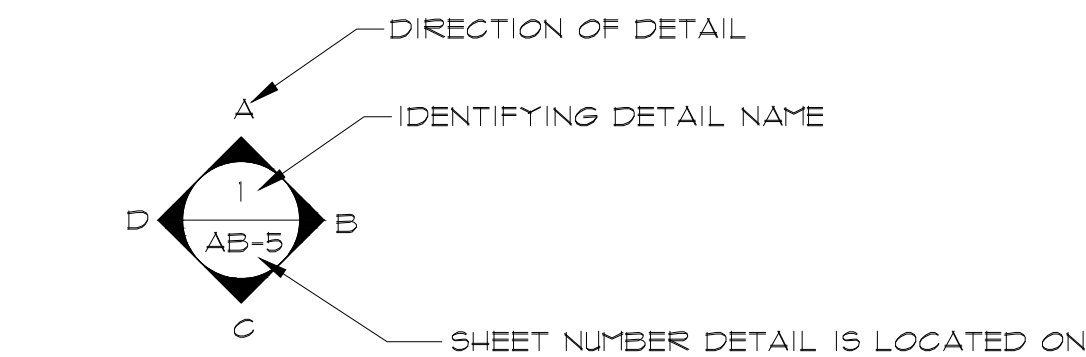

INTERIOR ELEVATIONS

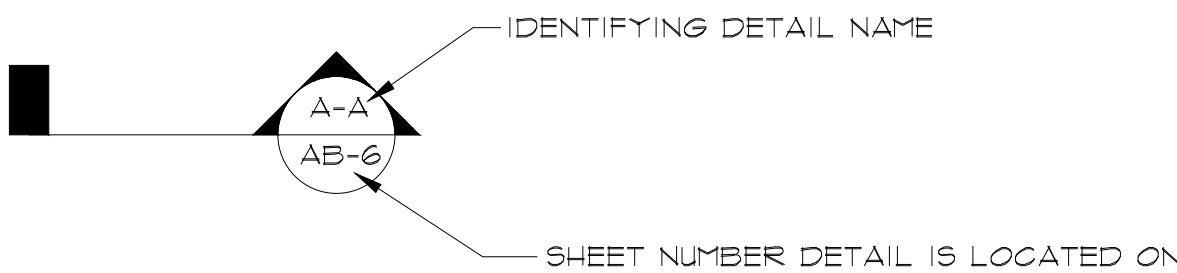

BUILDING SECTION

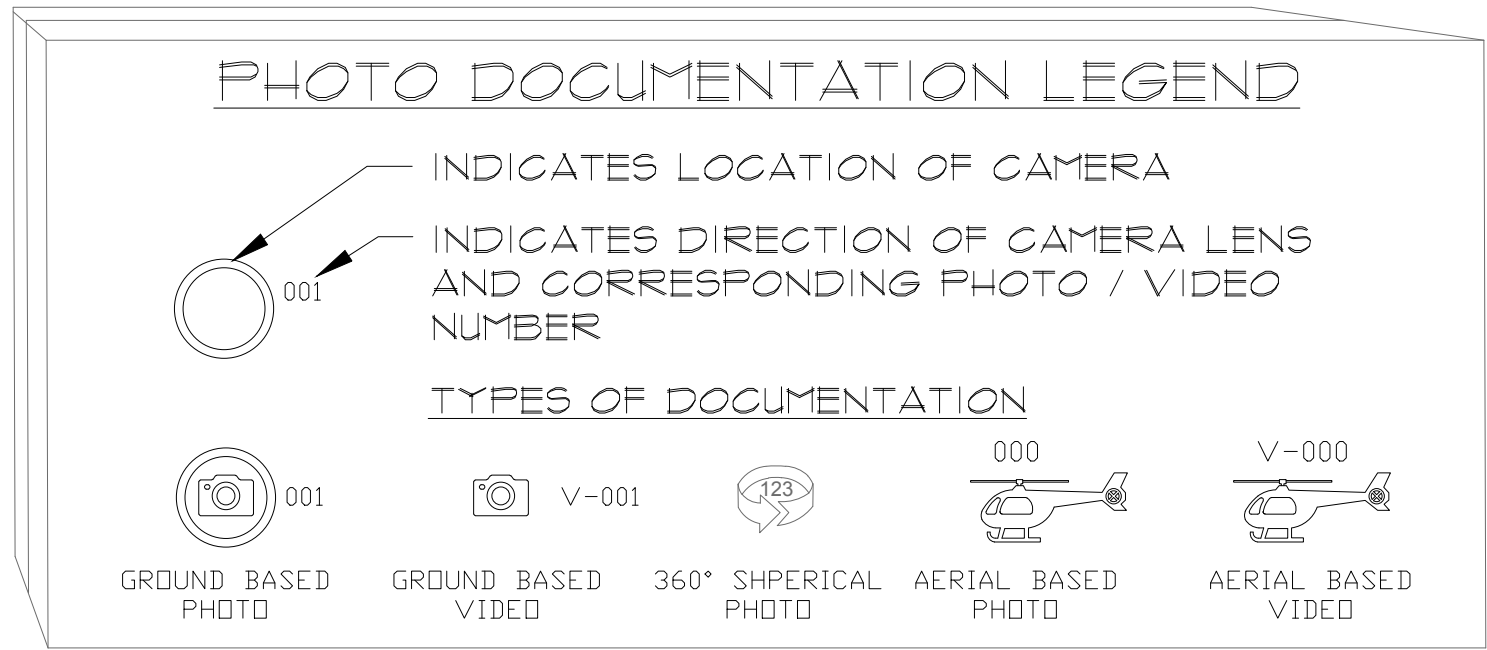

ARCHITECTURAL AS BUILT


Time Square Business Park

South Salt Lake City, UT 84115


01	100% SUBMISSION	SEE COVER SHEET
NO.	ISSUES REVISIONS	DATE
		SHEET TITLE
HL		PROJECT MANAGER
HL		PROJECT DIRECTOR
012317-1		PROJECT NUMBER
NOT TO SCALE		SCALE
CL		DRAWN BY
		SHEET NUMBER

SL

ALL AREA CALCULATIONS PER BOMA - Industrial Buildings: Standard Methods of Measurement (ANSI Z65.2 – 2012) & BOMA 2017 for Office Buildings: Standard Methods of Measurement (ANSI/BOMA Z65.1—2017)

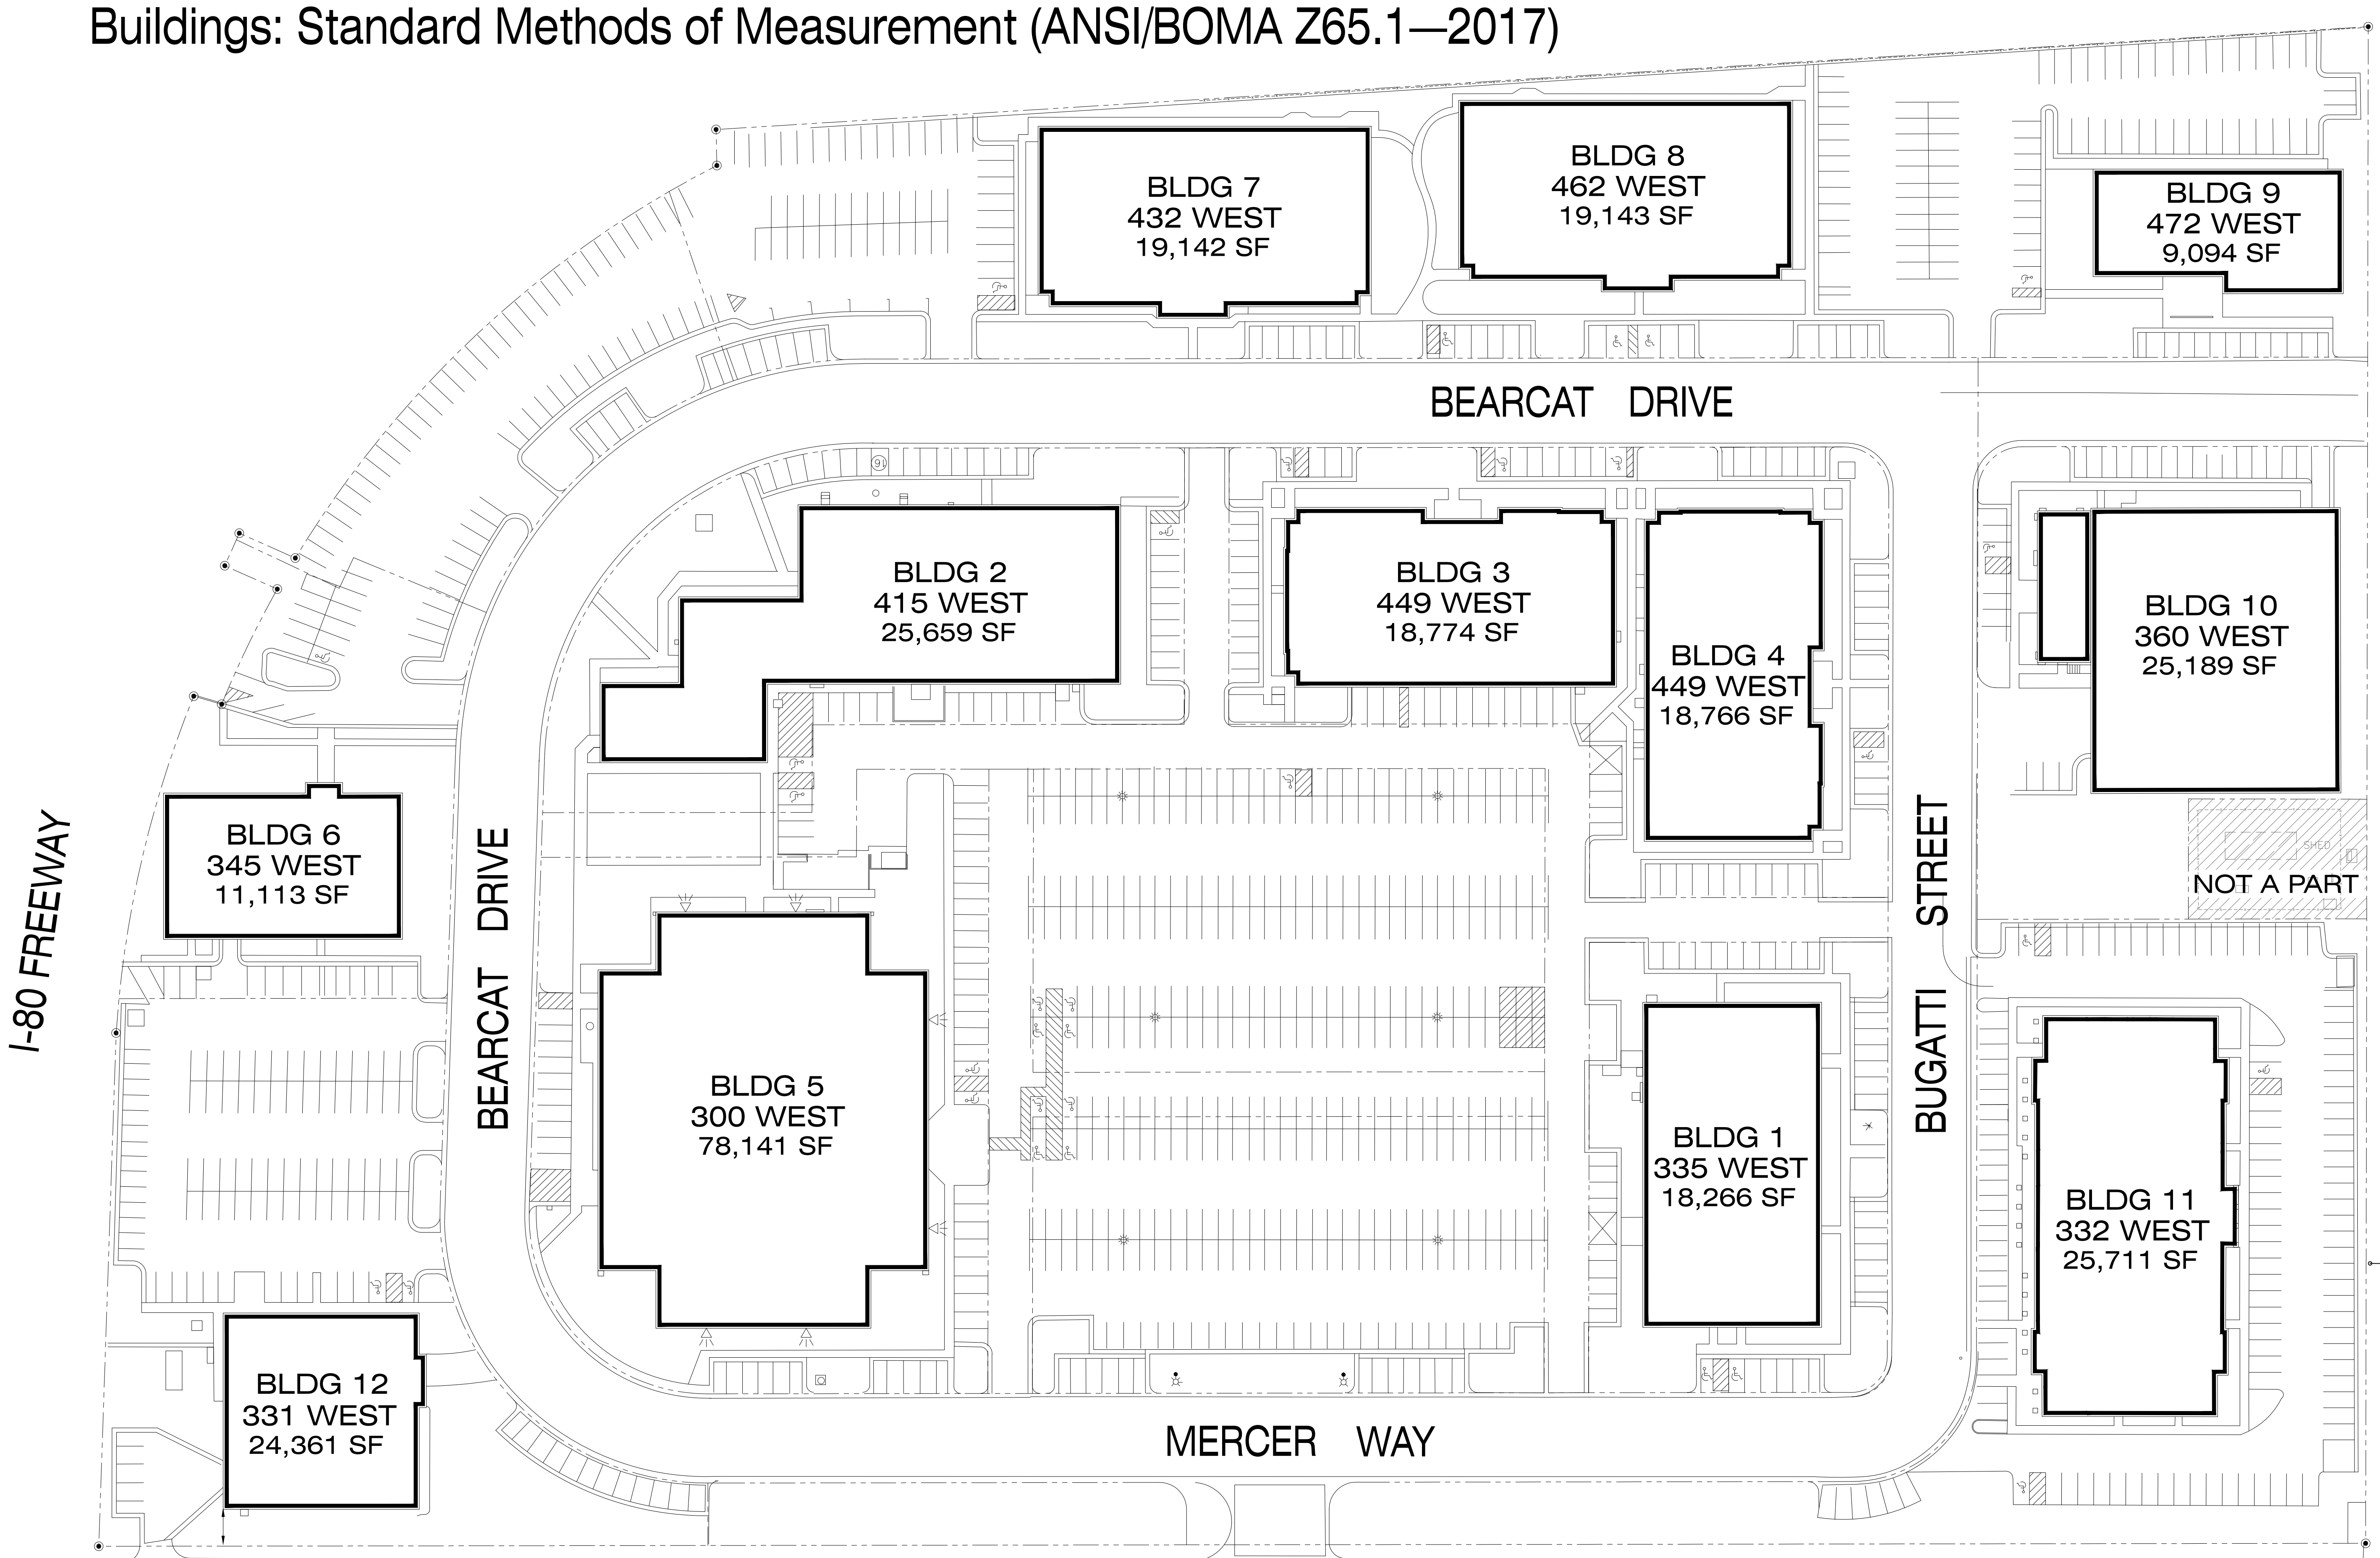

BUILDING LOCATIONS
GROSS BUILDING AREAS (SINGLE TENANT)

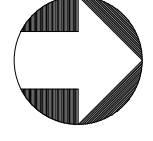 NORTH


AS BUILT
PROFESSIONALS
www.asbuiltprofessionals.com
A DIVISION OF:


AEC
CONSULTANTS INC
844.272.8458
844 AS BUILT

© 2019 AEC CONSULTANTS INC

ARCHITECTURAL AS BUILT
Time Square Business Park
South Salt Lake City, UT 84115

01	100% SUBMISSION	SEE COVER SHEET
NO.	ISSUES REVISIONS	DATE
		SHEET TITLE
		PROJECT MANAGER
		PROJECT DIRECTOR
012317-1		PROJECT NUMBER
NOT TO SCALE		SCALE
CL		DRAWN BY
		SHEET NUMBER

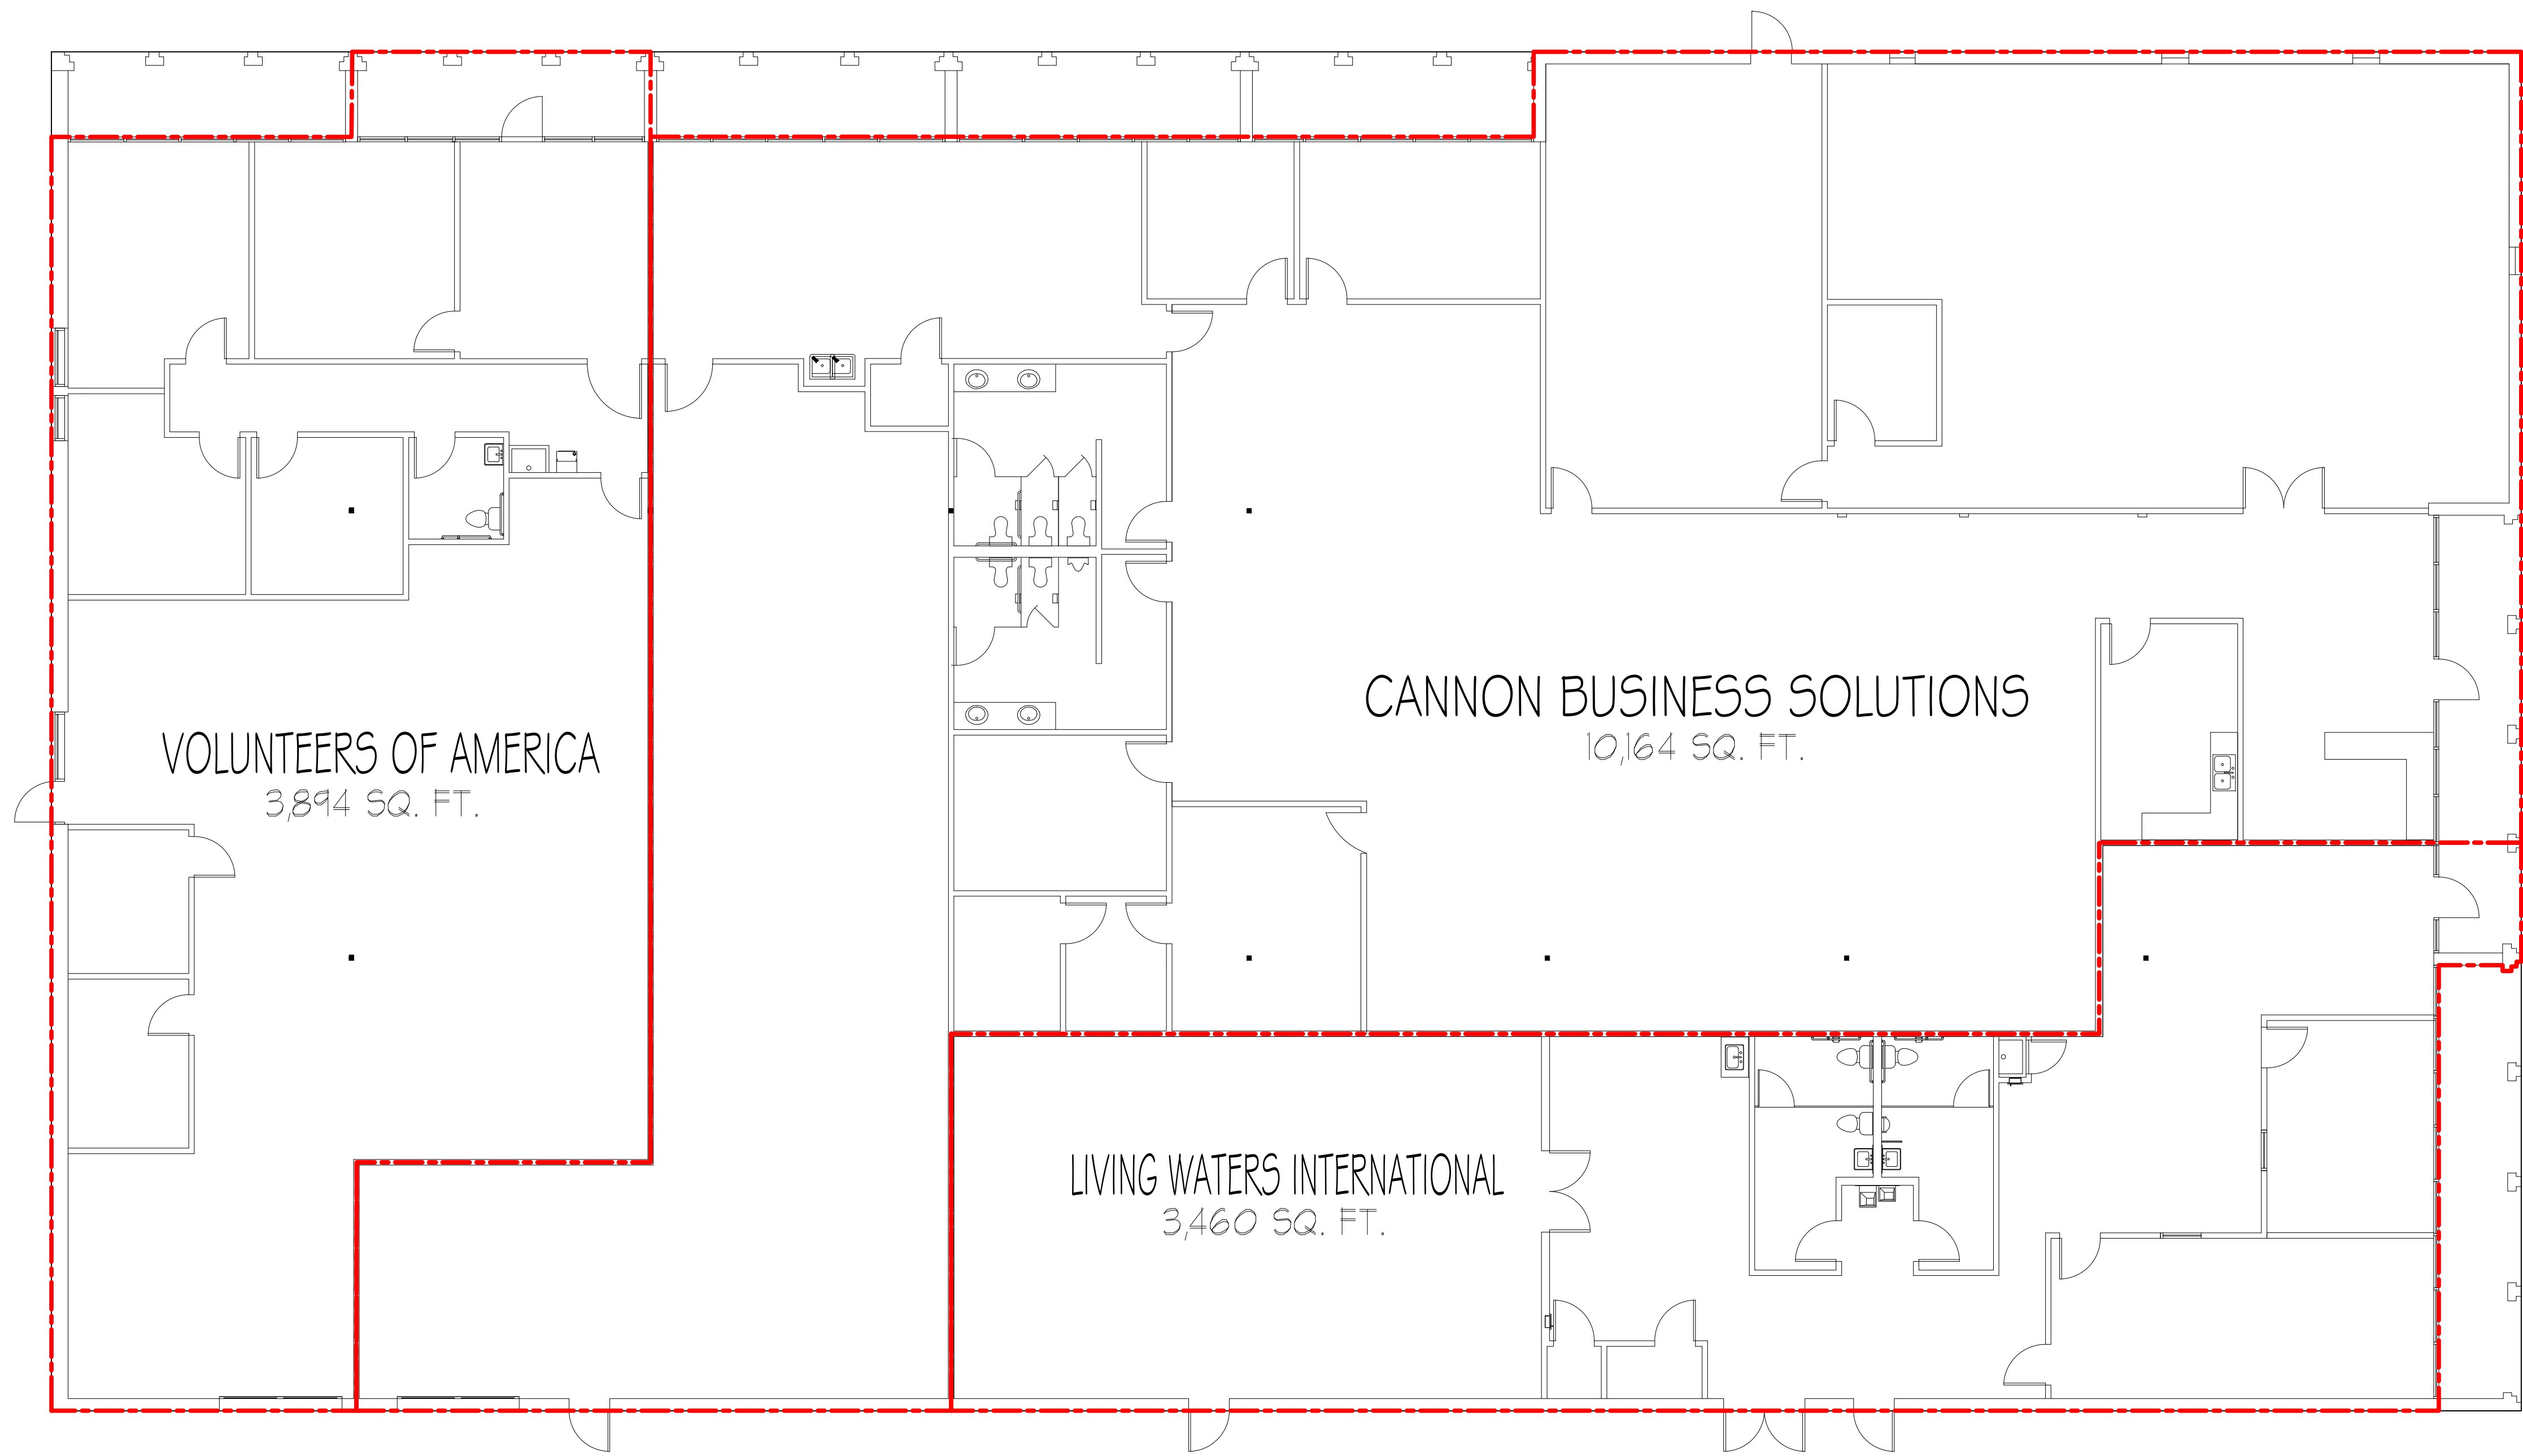

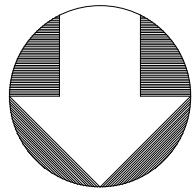BLDG 1 FLOOR PLAN 18,266 RSA (SINGLE TENANT) 



As BUILT
PROFESSIONALS
www.asbuiltprofessionals.com
A DIVISION OF:




AEC
CONSULTANTS INC
844.272.8458
844 AS BUILT


© 2019 AEC CONSULTANTS INC

ARCHITECTURAL AS BUILT
Time Square Business Park
South Salt Lake City, UT 84115

01	100% SUBMISSION	SEE COVER SHEET
NO.	ISSUES REVISIONS	DATE
		SHEET TITLE
HL	PROJECT MANAGER	
HL	PROJECT DIRECTOR	
012317-1	PROJECT NUMBER	
1/8"=1'-0"	SCALE	
CL	DRAWN BY	
SHEET NUMBER		

AB-1

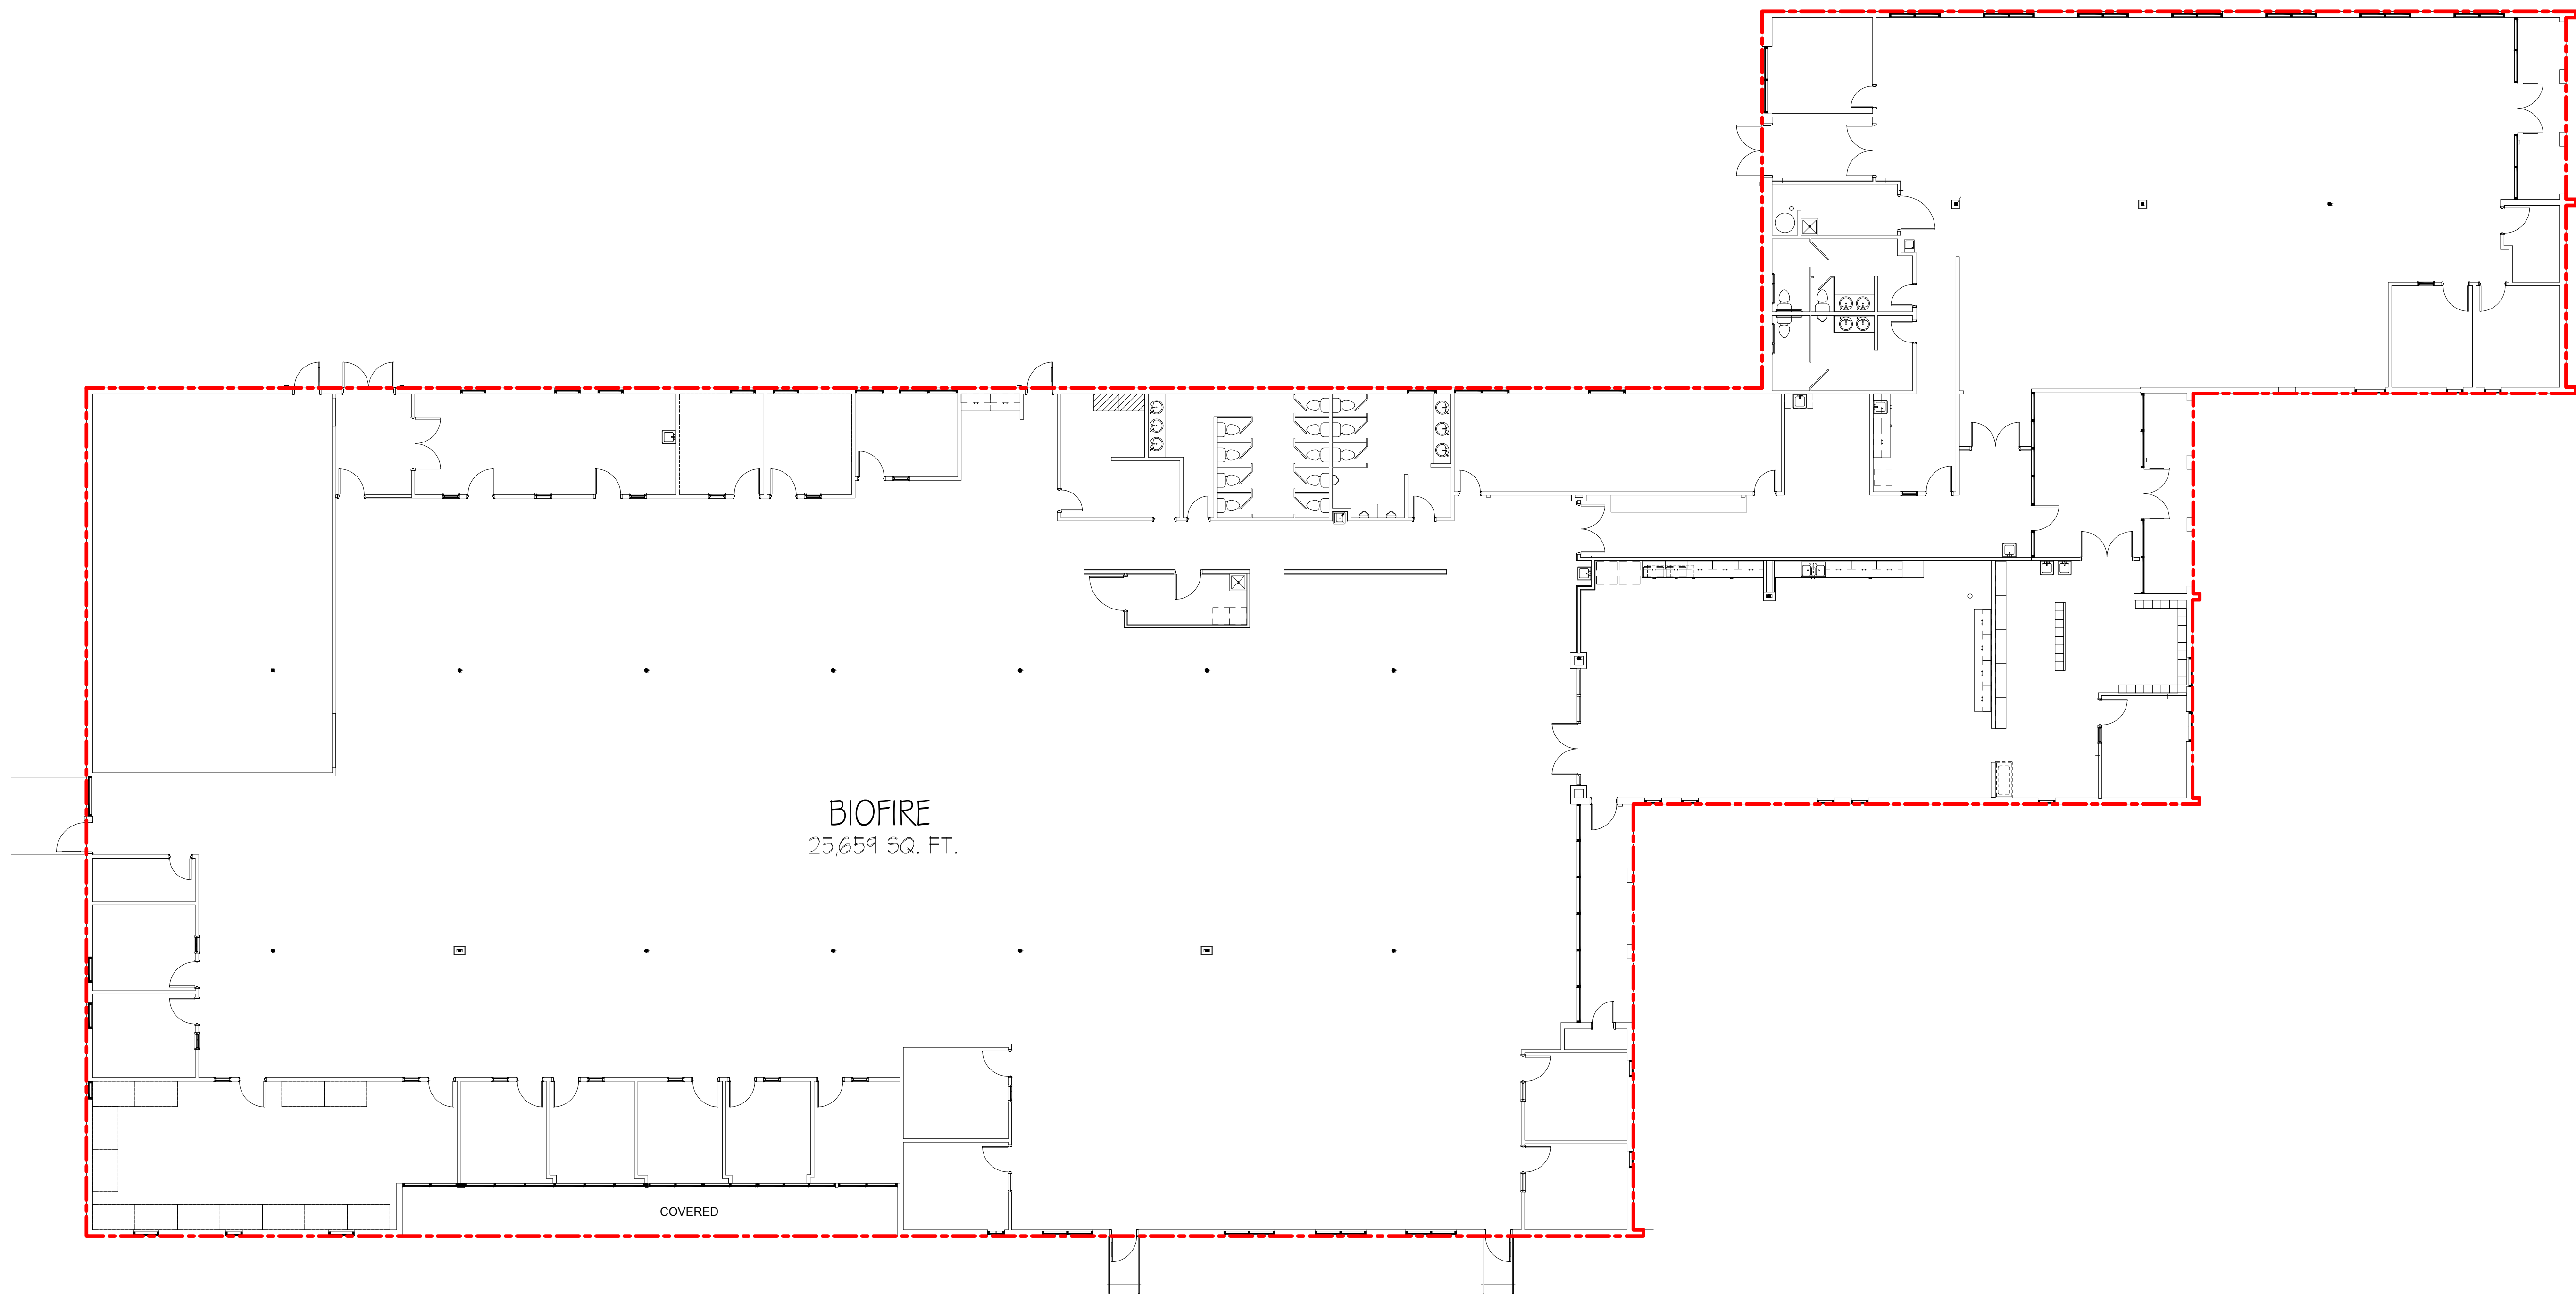

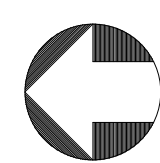BLDG 2 FLOOR PLAN 25,659 RSA (SINGLE TENANT) 

As BUILT

PROFESSIONALS

www.asbuiltprofessionals.com

A DIVISION OF:

AEC

CONSULTANTS INC

844.272.8458


844 AS BUILT


@ 2019 AEC CONSULTANTS INC

ARCHITECTURAL AS BUILT
Time Square Business Park
South Salt Lake City, UT 84115

01	100% SUBMISSION	SEE COVER SHEET
NO.	ISSUES REVISIONS	DATE
		SHEET TITLE
HL		PROJECT MANAGER
HL		PROJECT DIRECTOR
012317-1		PROJECT NUMBER
3/32"=1'-0"		SCALE
CL		DRAWN BY
		SHEET NUMBER

AB-2

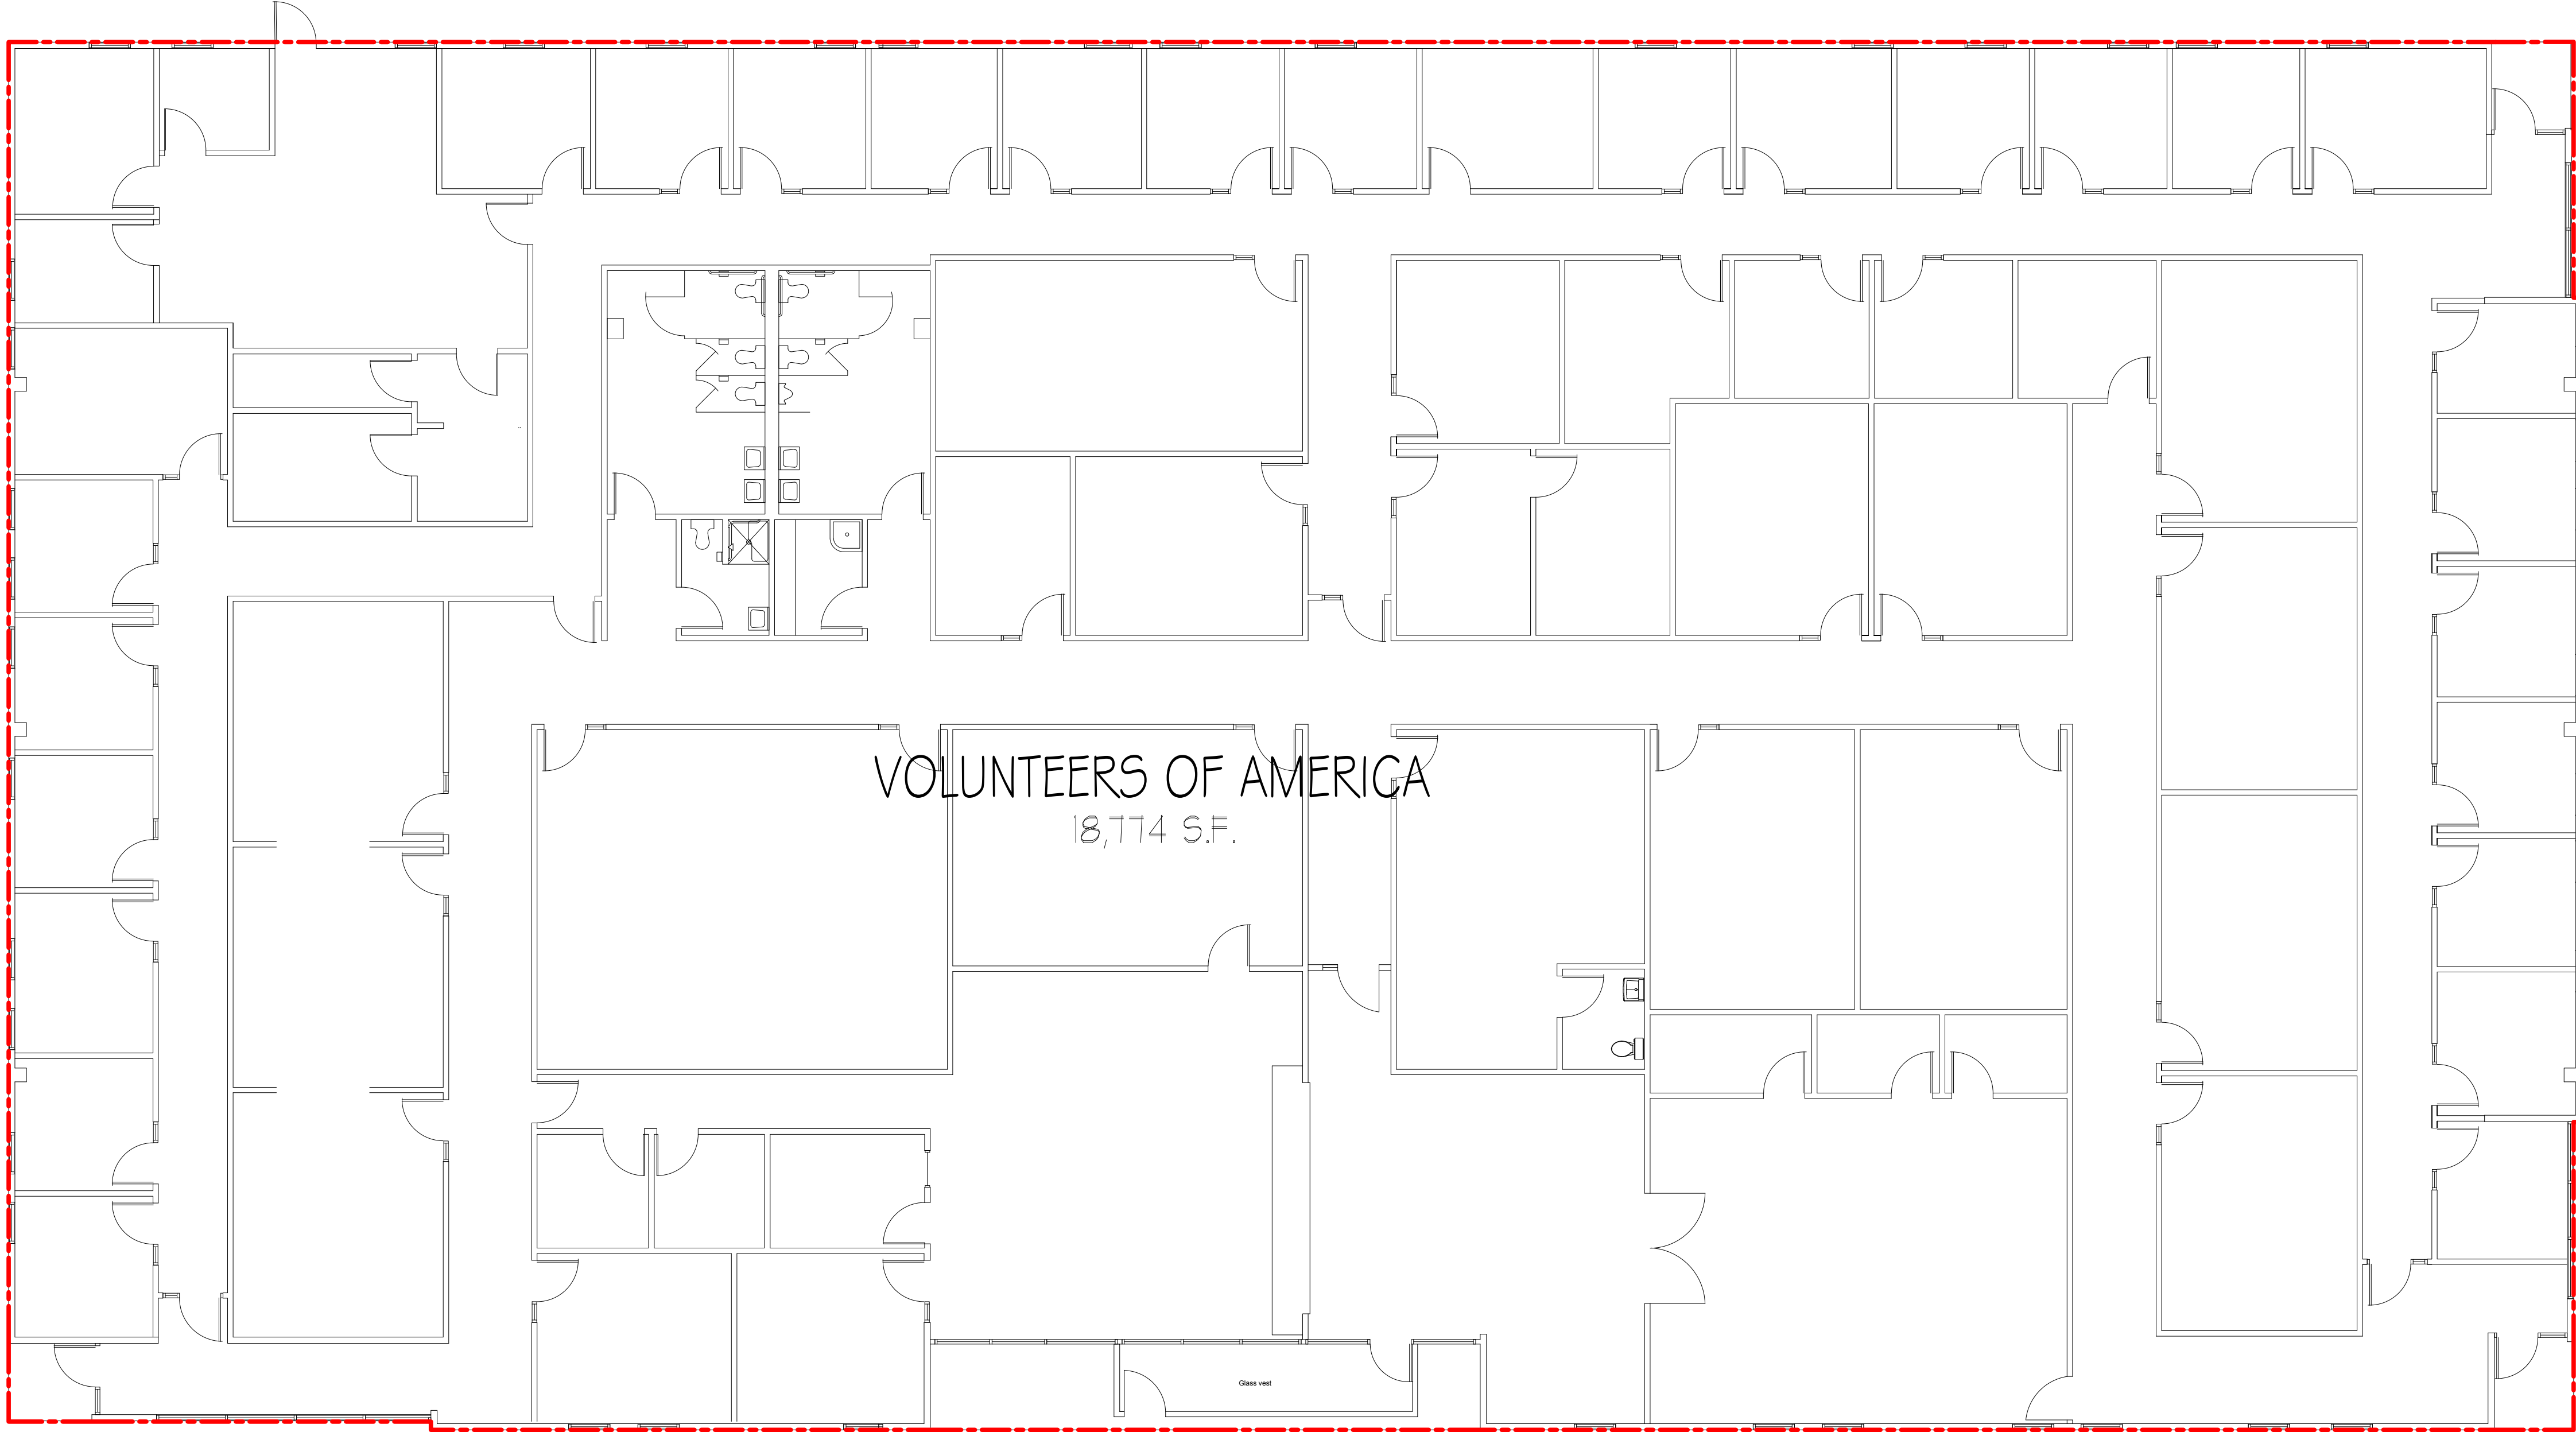

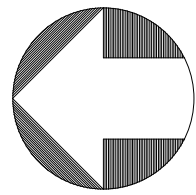BLDG 3 FLOOR PLAN 18,774 RSA (SINGLE TENANT) 

As BUILT

PROFESSIONALS

www.asbuiltprofessionals.com

A DIVISION OF:

AEC

CONSULTANTS INC

844.272.8458

844 AS BUILT

© 2019 AEC CONSULTANTS INC

ARCHITECTURAL AS BUILT
Time Square Business Park
South Salt Lake City, UT 84115

01	100% SUBMISSION	SEE COVER SHEET
NO.	ISSUES REVISIONS	DATE
		SHEET TITLE
HL		PROJECT MANAGER
HL		PROJECT DIRECTOR
012317-1		PROJECT NUMBER
1/8"=1'-0"		SCALE
CL		DRAWN BY
		SHEET NUMBER

AB-3



AB-4



BLDG 5 FIRST FLOOR PLAN 39,081 RSA (SINGLE TENANT) 



As BUILT
PROFESSIONALS
www.asbuiltprofessionals.com
A DIVISION OF:




AEC
CONSULTANTS INC
844.272.8458
844 ASBUILT

© 2019 AEC CONSULTANTS INC

ARCHITECTURAL AS BUILT
Time Square Business Park
South Salt Lake City, UT 84115

01	100% SUBMISSION	SEE COVER SHEET
NO.	ISSUES REVISIONS	DATE
		SHEET TITLE
HL	PROJECT MANAGER	
HL	PROJECT DIRECTOR	
012317-1	PROJECT NUMBER	
3/32"=1'-0"	SCALE	
CL	DRAWN BY	
		SHEET NUMBER
AB-5.1		

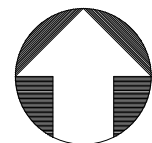

BLDG 5 SECOND FLOOR PLAN 39,060 RSA (SINGLE TENANT) 

AS BUILT
PROFESSIONALS
www.asbuiltprofessionals.com
A DIVISION OF:


AEC
CONSULTANTS INC
844.272.8458
844 AS BUILT

© 2019 AEC CONSULTANTS INC


ARCHITECTURAL AS BUILT
Time Square Business Park
South Salt Lake City, UT 84115

01	100% SUBMISSION	SEE COVER SHEET
NO.	ISSUES REVISIONS	DATE
		SHEET TITLE
HL	PROJECT MANAGER	
HL	PROJECT DIRECTOR	
012317-1	PROJECT NUMBER	
3/32"=1'-0"	SCALE	
CL	DRAWN BY	
	SHEET NUMBER	

AB-5.2

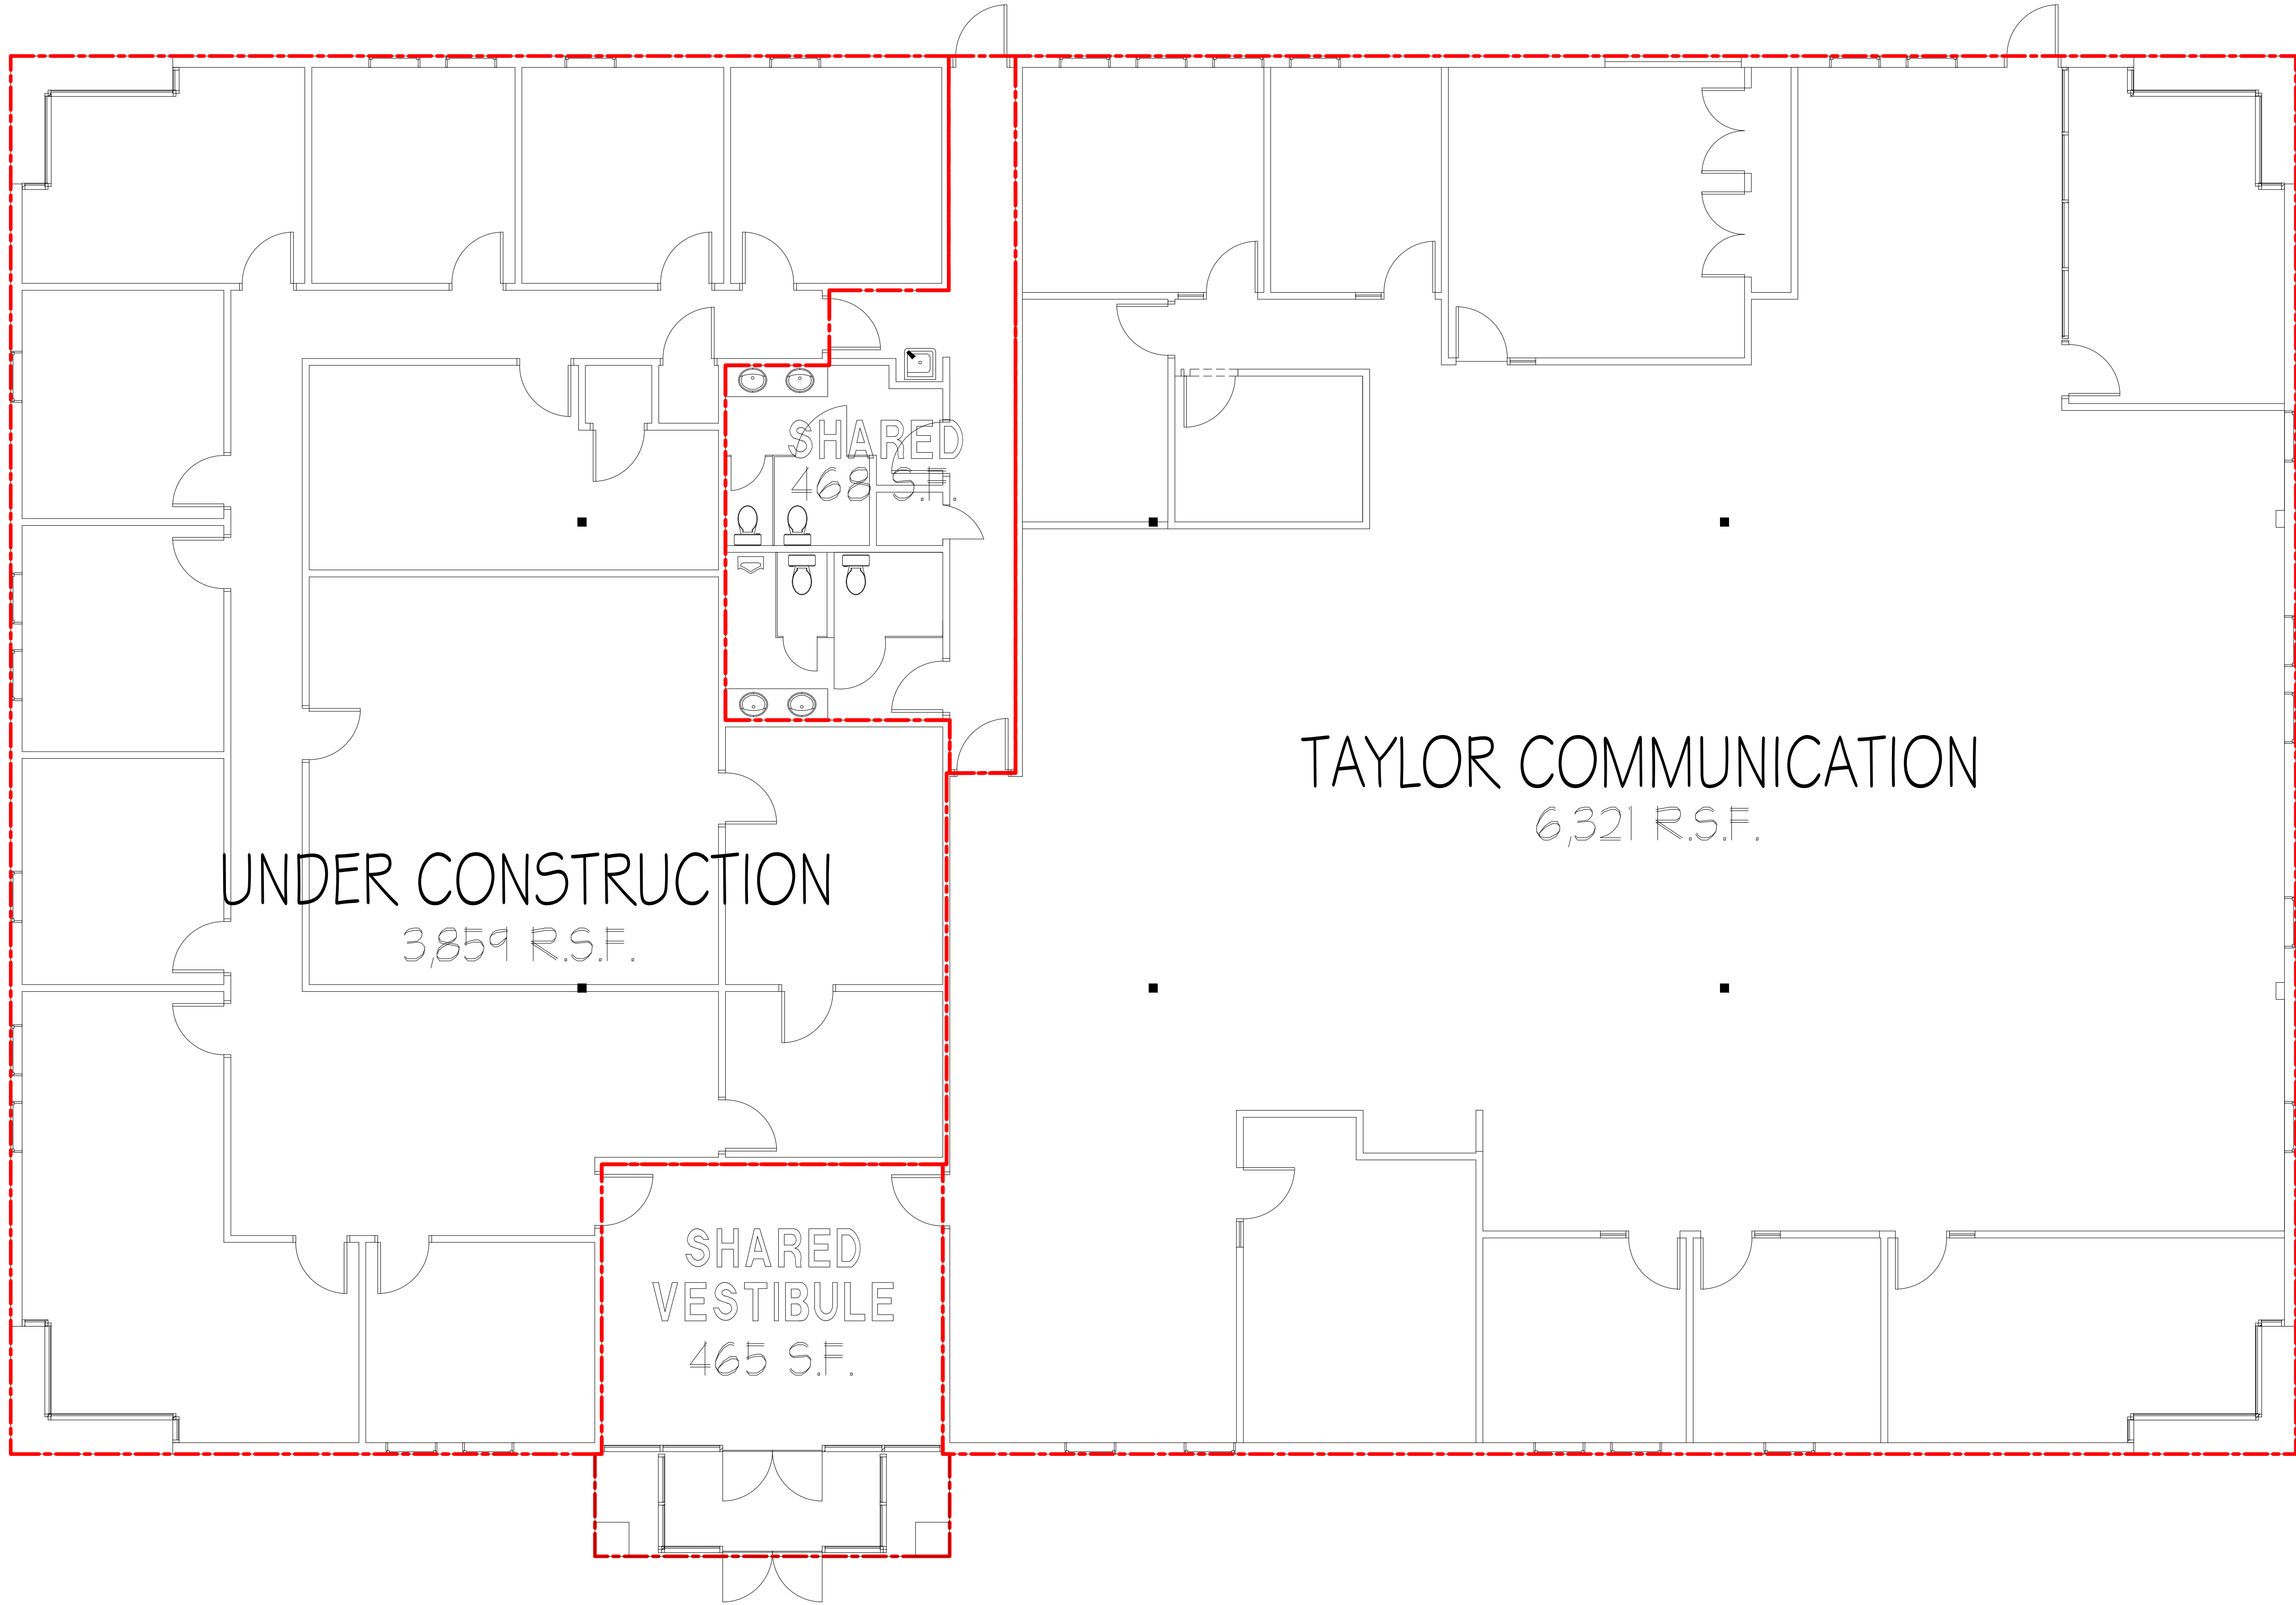

BLDG 6 FLOOR PLAN 11,113 RSA (SINGLE TENANT)

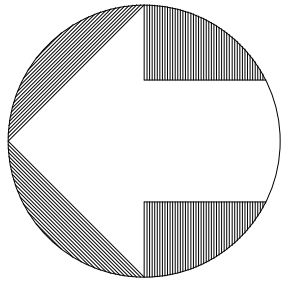

AS BUILT
PROFESSIONALS
www.asbuiltprofessionals.com
A DIVISION OF:


AEC
CONSULTANTS INC
844.272.8458
844 AS BUILT


© 2019 AEC CONSULTANTS INC

ARCHITECTURAL AS BUILT
Time Square Business Park
South Salt Lake City, UT 84115

01	100% SUBMISSION	SEE COVER SHEET
NO.	ISSUES REVISIONS	DATE
		SHEET TITLE
HL	PROJECT MANAGER	
HL	PROJECT DIRECTOR	
012317-1	PROJECT NUMBER	
3/16"=1'-0"	SCALE	
CL	DRAWN BY	
		SHEET NUMBER

AB-6

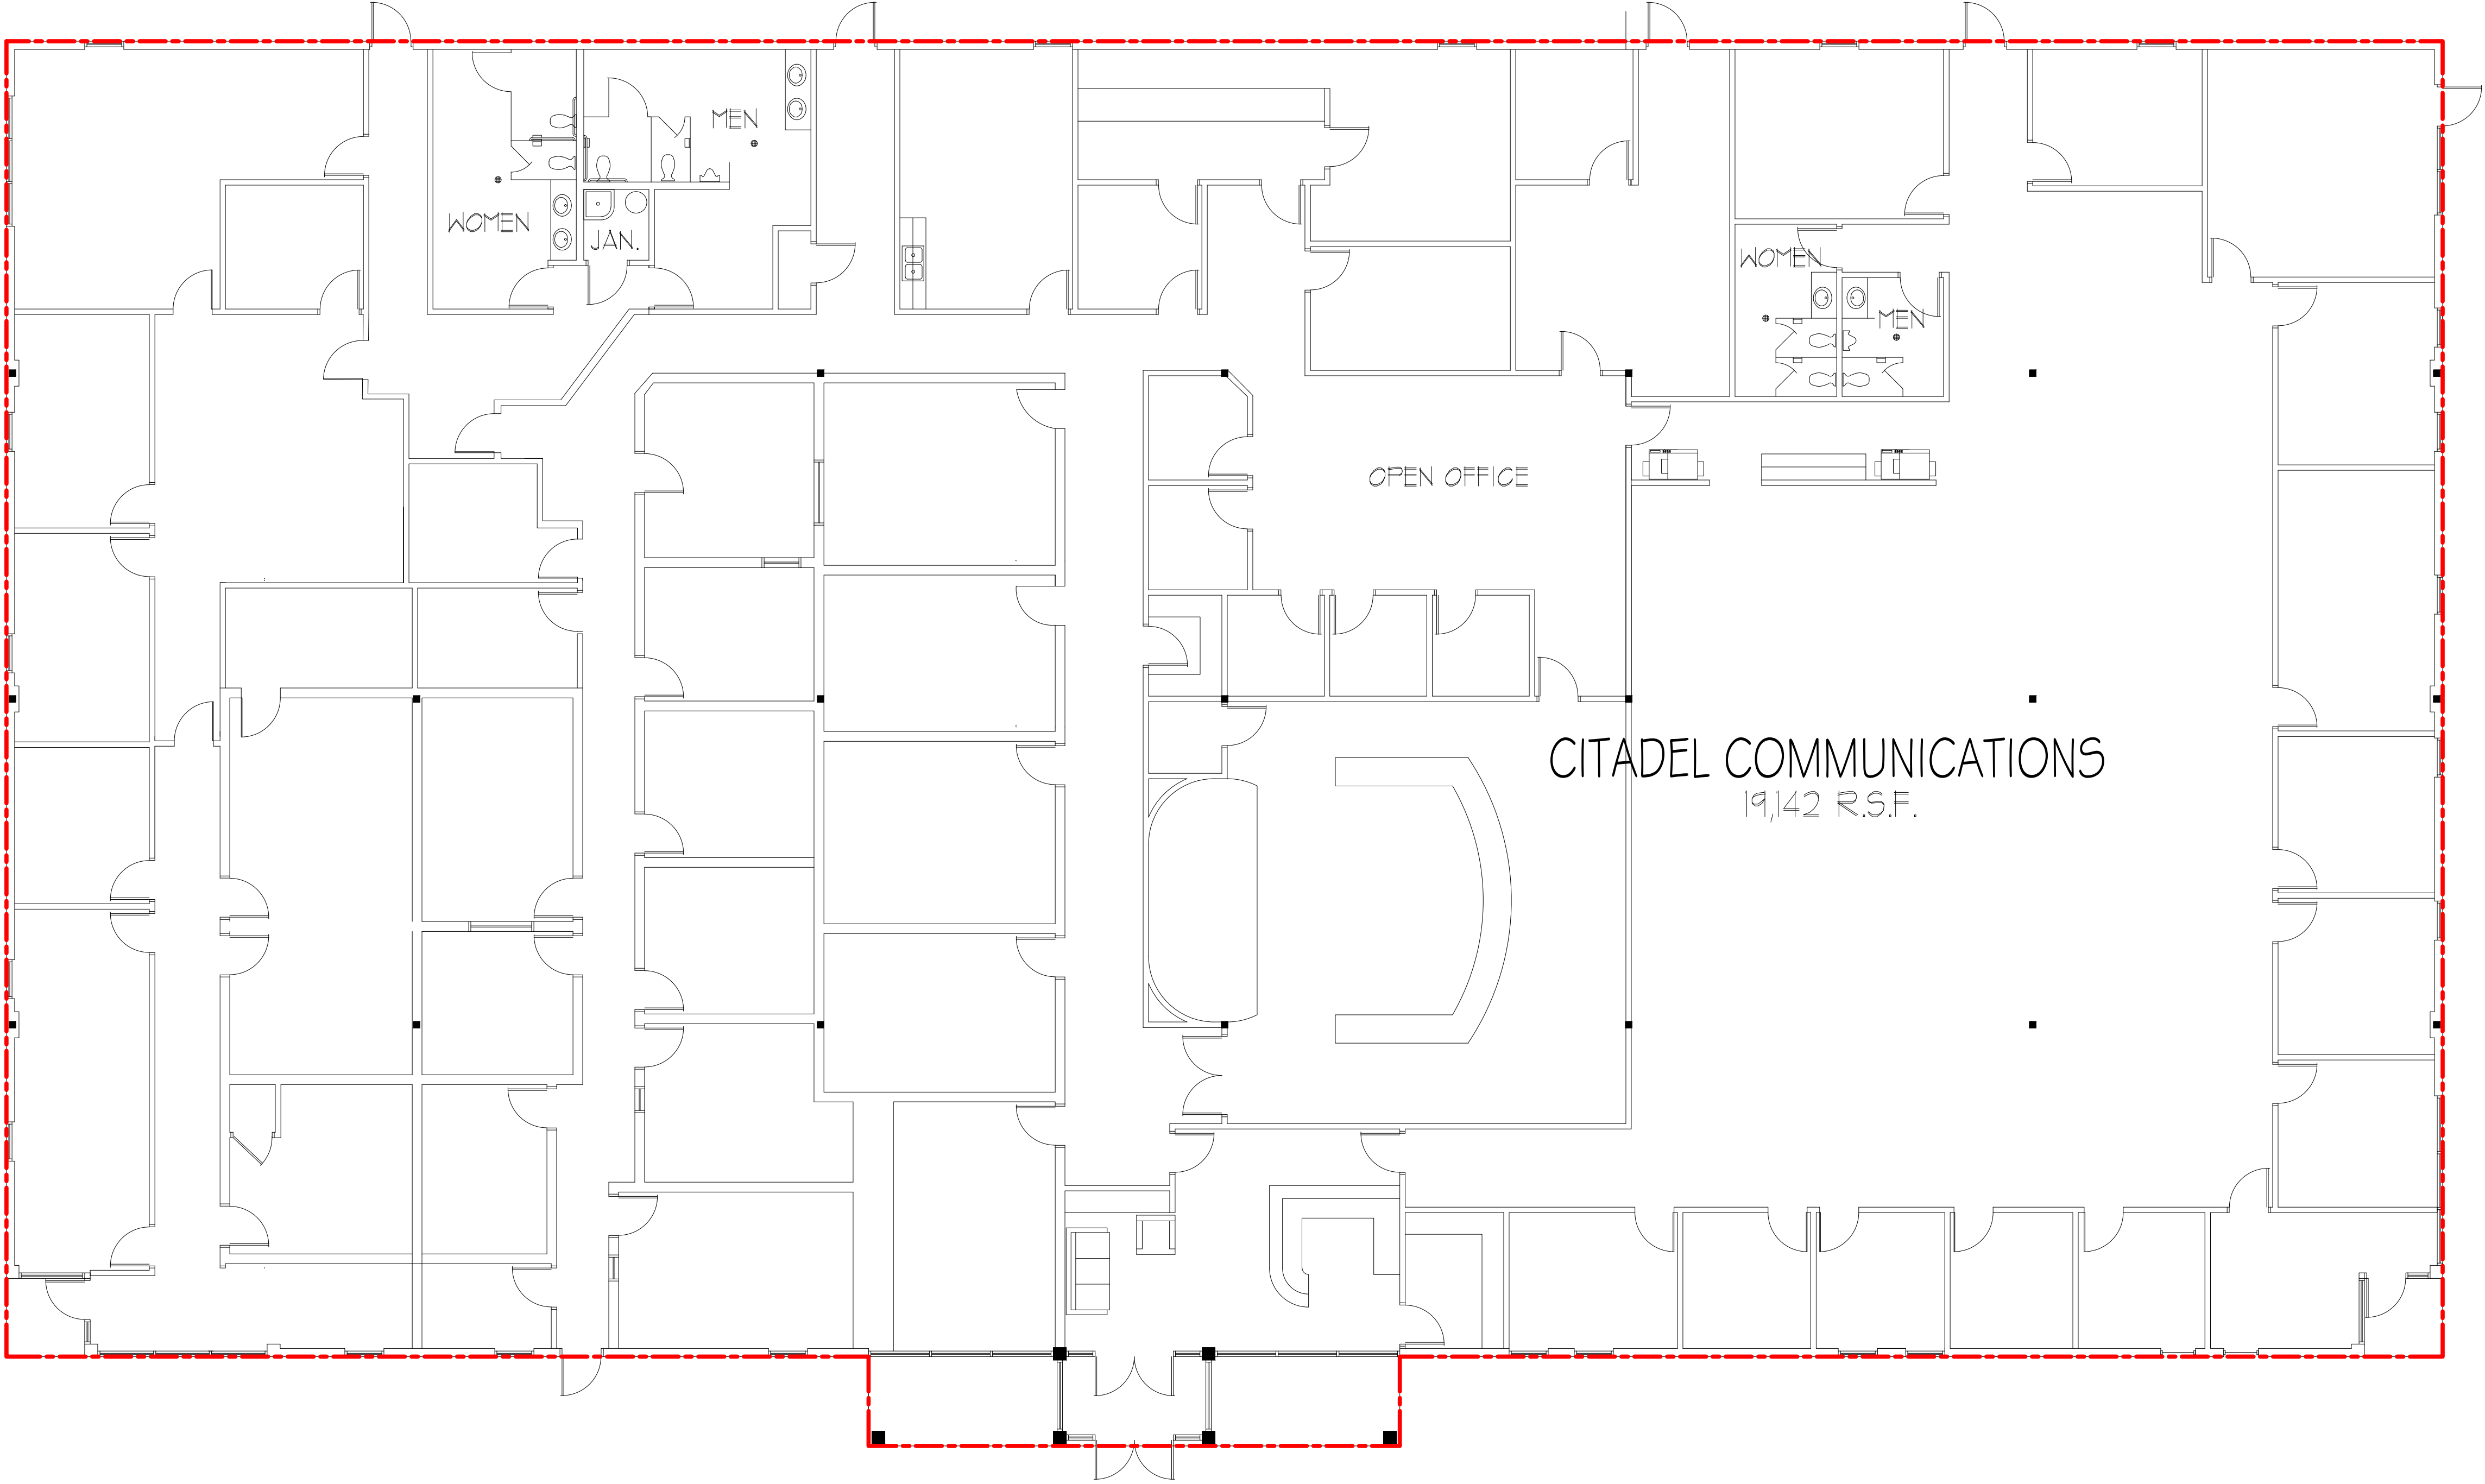

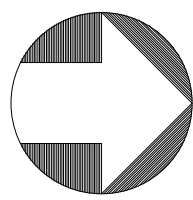BLDG 7 FLOOR PLAN 19,142 RSA (SINGLE TENANT) 

As BUILT

PROFESSIONALS

www.asbuiltprofessionals.com

A DIVISION OF:

AEC

CONSULTANTS INC

844.272.8458


844 AS BUILT


@ 2019 AEC CONSULTANTS INC

ARCHITECTURAL AS BUILT
Time Square Business Park
South Salt Lake City, UT 84115

01	100% SUBMISSION	SEE COVER SHEET
NO.	ISSUES REVISIONS	DATE
		SHEET TITLE
HL		PROJECT MANAGER
HL		PROJECT DIRECTOR
012317-1		PROJECT NUMBER
1/8"=1'-0"		SCALE
CL		DRAWN BY
		SHEET NUMBER

AB-7

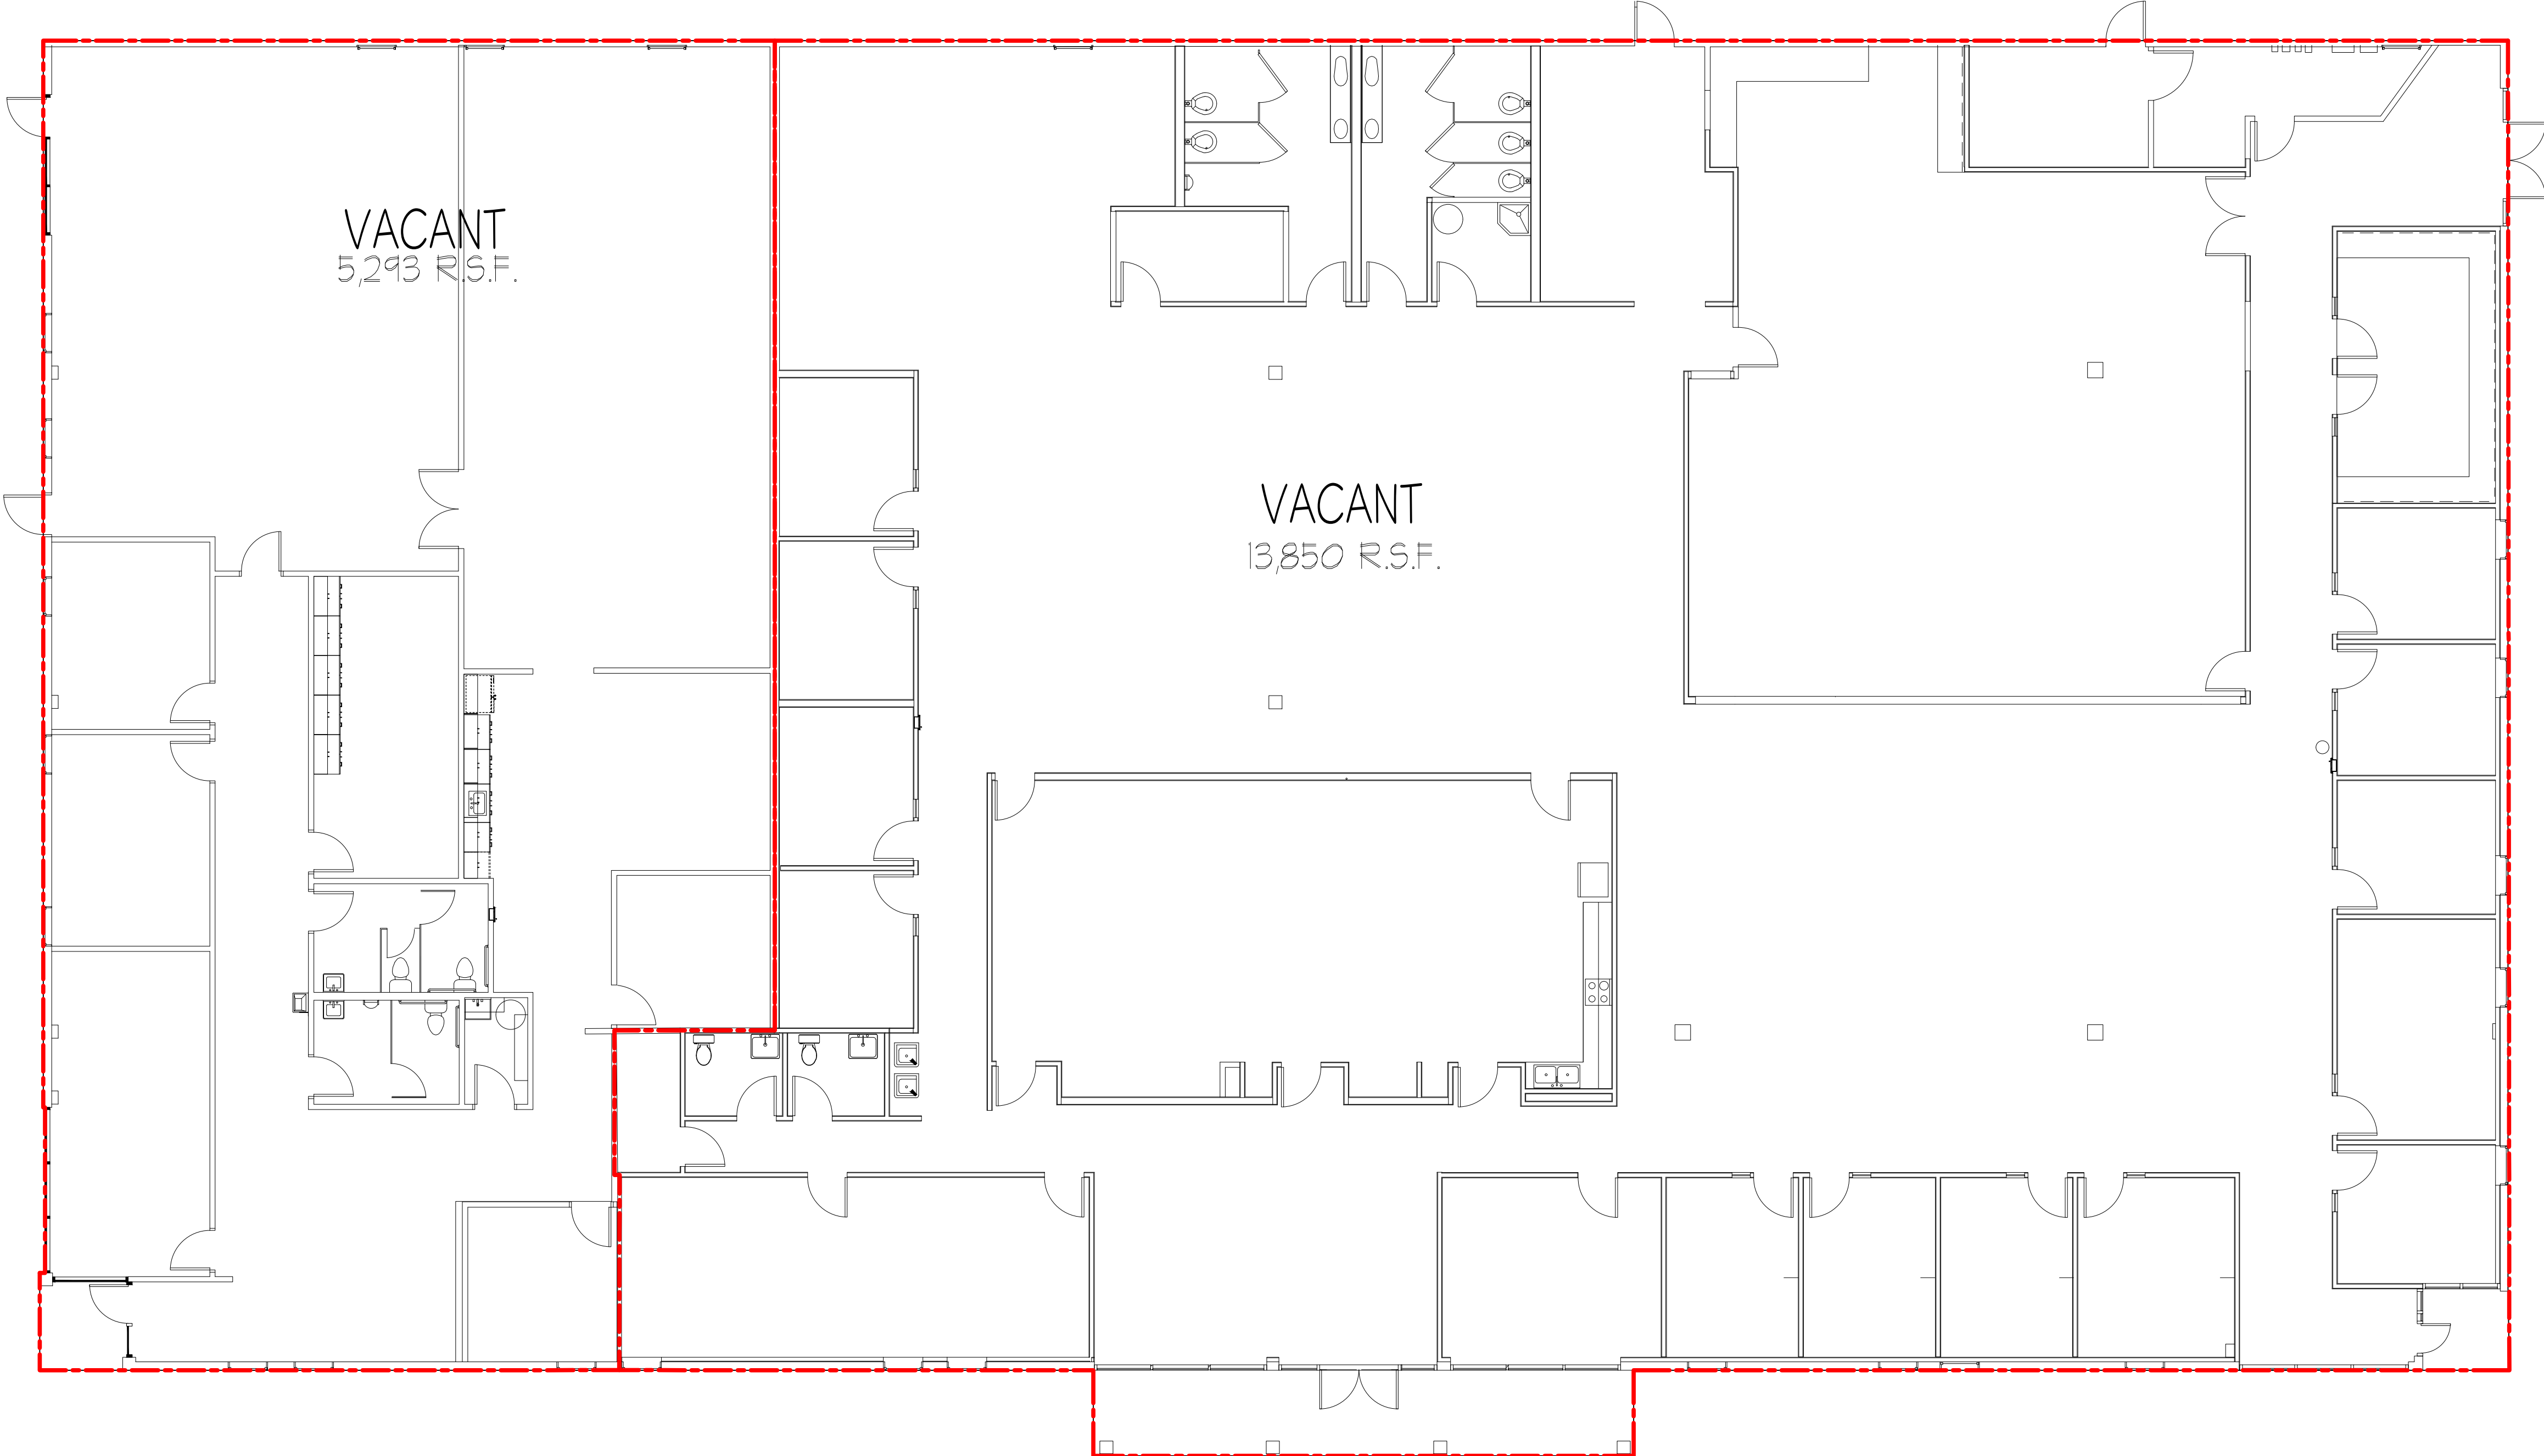

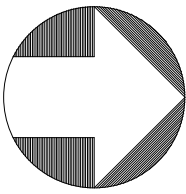BLDG 8 FLOOR PLAN 19,143 RSA (SINGLE TENANT) 

As BUILT

PROFESSIONALS

www.asbuiltprofessionals.com

A DIVISION OF:

AEC

CONSULTANTS INC

844.272.8458


844 AS BUILT

© 2019 AEC CONSULTANTS INC


ARCHITECTURAL AS BUILT
Time Square Business Park
South Salt Lake City, UT 84115

01	100% SUBMISSION	SEE COVER SHEET
NO.	ISSUES REVISIONS	DATE
		SHEET TITLE
HL		PROJECT MANAGER
HL		PROJECT DIRECTOR
012317-1		PROJECT NUMBER
1/8"=1'-0"		SCALE
CL		DRAWN BY
		SHEET NUMBER

AB-8

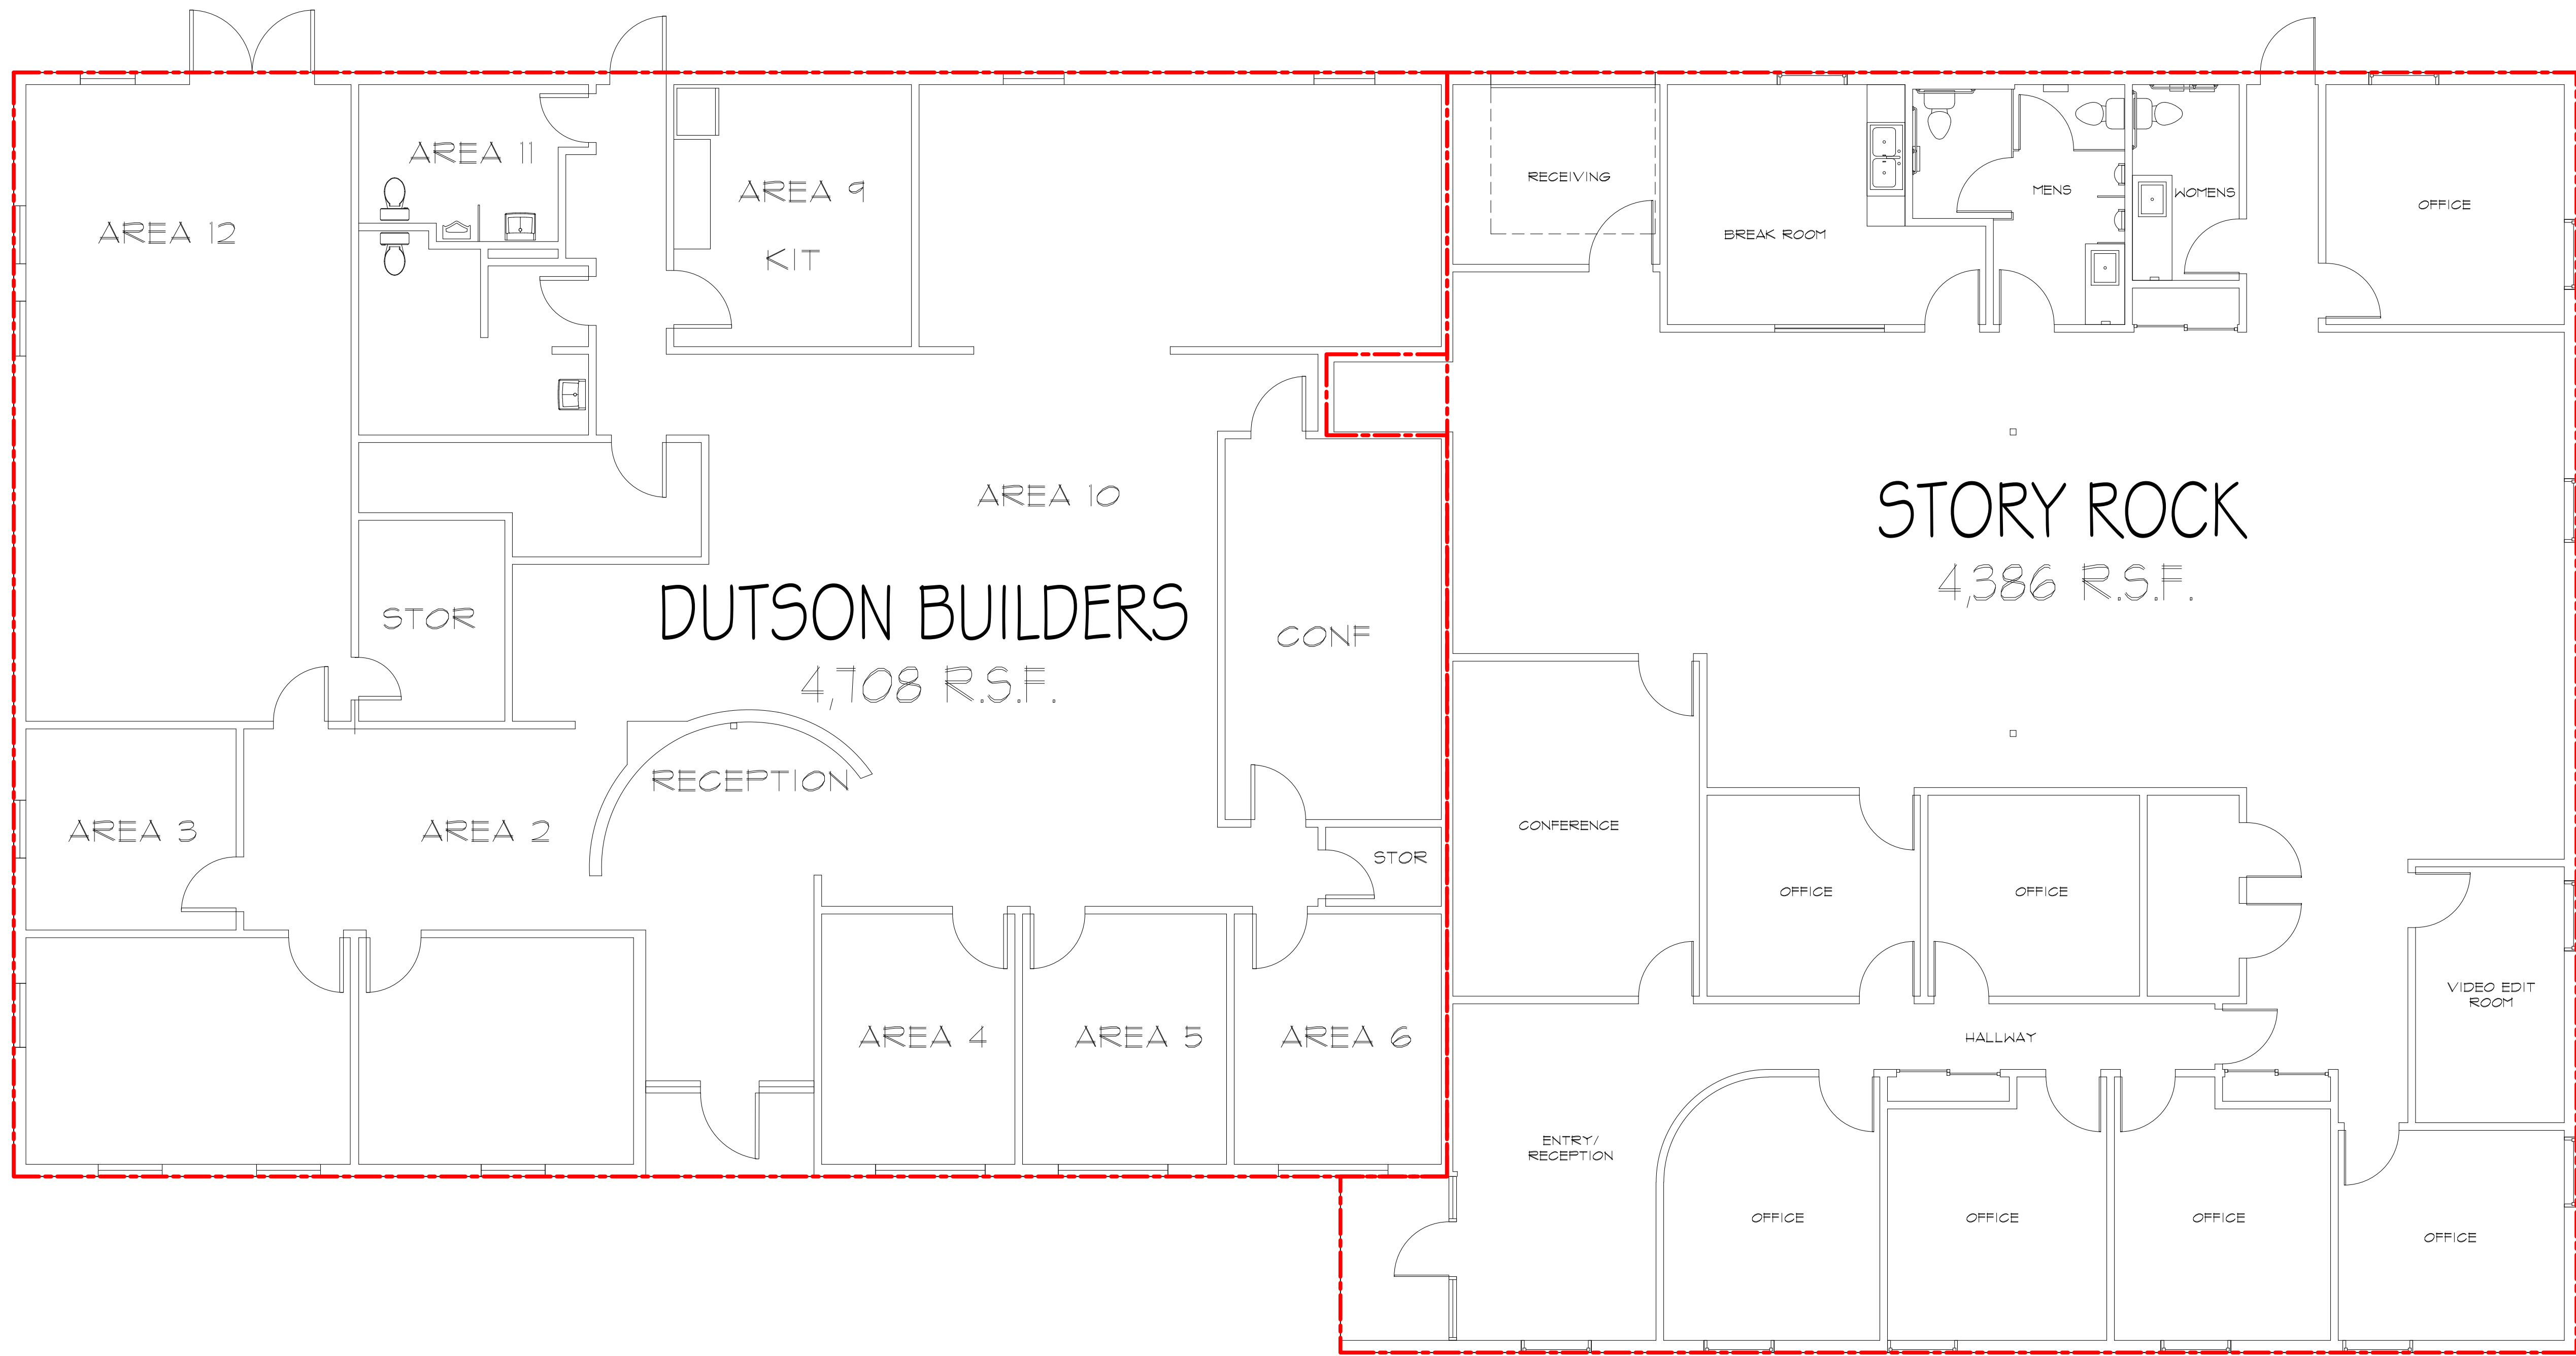

BLDG 9 FLOOR PLAN 9,094 RSA (SINGLE TENANT)

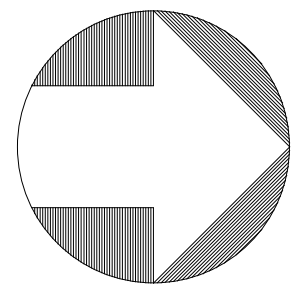

As BUILT

PROFESSIONALS

www.asbuiltprofessionals.com

A DIVISION OF:

AEC

CONSULTANTS INC

844.272.8458


844 AS BUILT

© 2019 AEC CONSULTANTS INC

ARCHITECTURAL AS BUILT
Time Square Business Park
South Salt Lake City, UT 84115

01	100% SUBMISSION	SEE COVER SHEET
NO.	ISSUES REVISIONS	DATE
		SHEET TITLE
HL	PROJECT MANAGER	
HL	PROJECT DIRECTOR	
012317-1	PROJECT NUMBER	
3/16"=1'-0"		SCALE
CL	DRAWN BY	
		SHEET NUMBER

AB-9

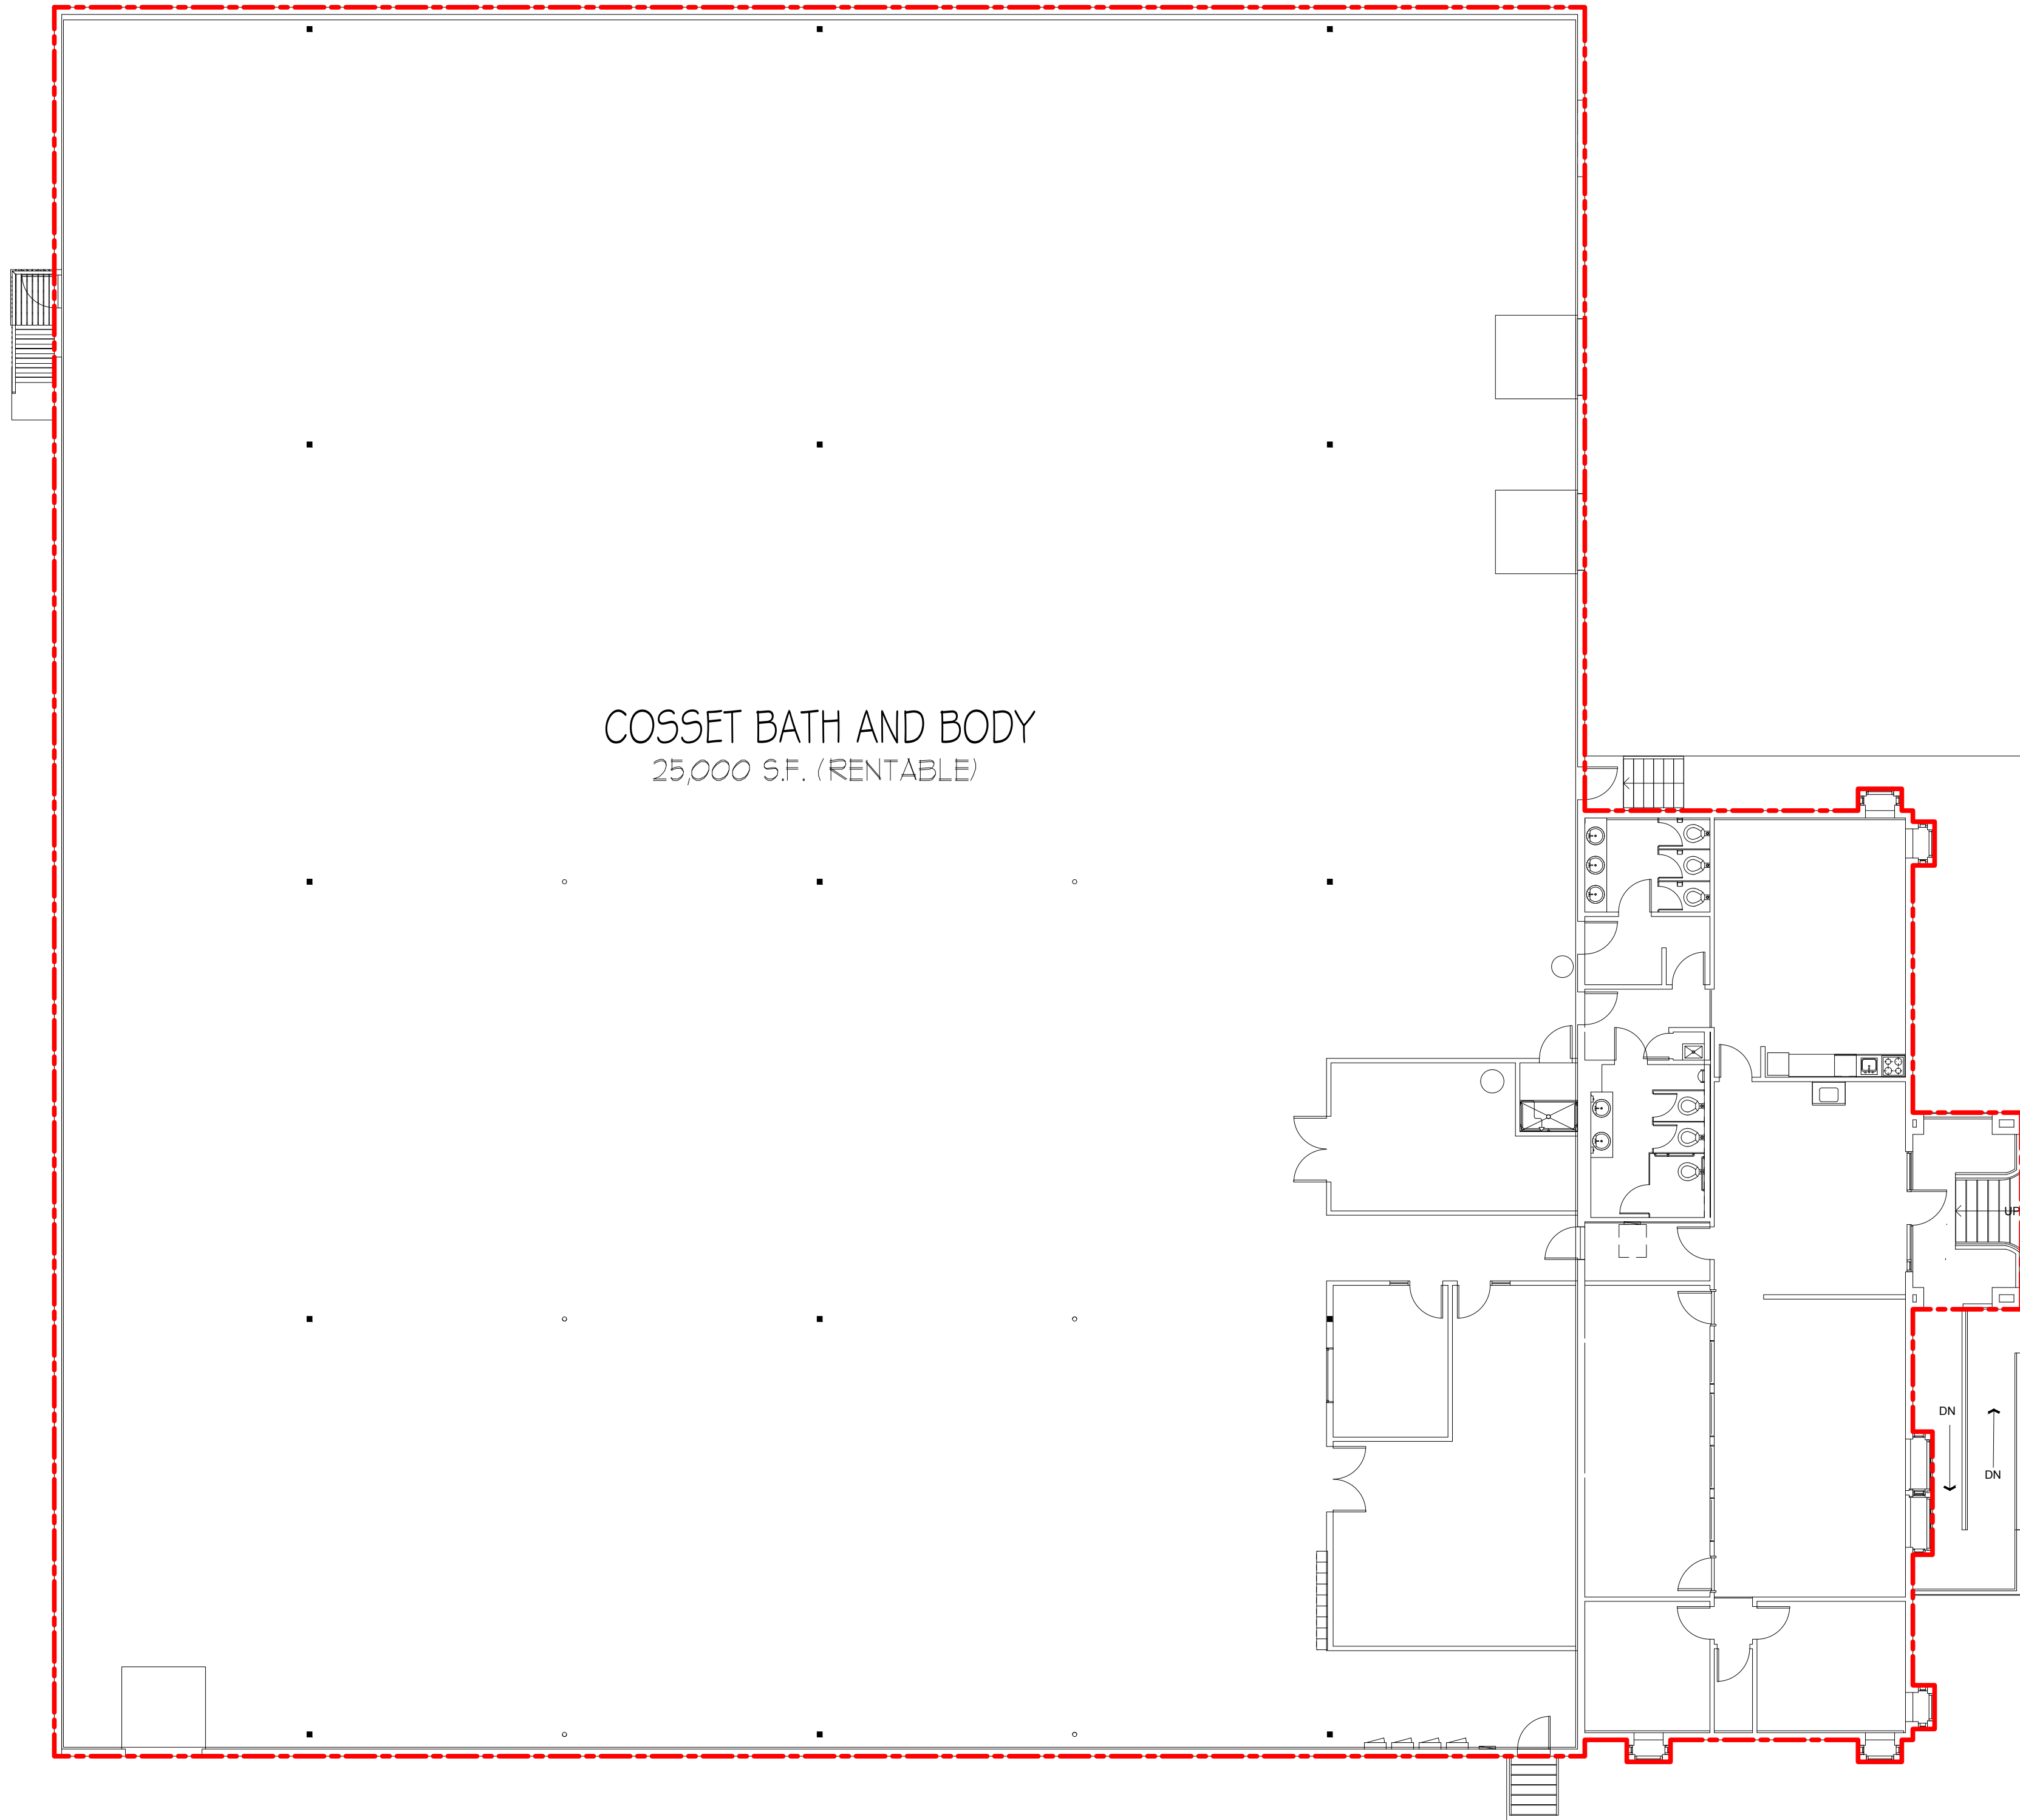

BLDG 10 FLOOR PLAN 25,189 RSA (SINGLE TENANT) 



As BUILT
PROFESSIONALS
www.asbuiltprofessionals.com
A DIVISION OF:





AEC
CONSULTANTS INC
844.272.8458
844 AS BUILT

© 2019 AEC CONSULTANTS INC

ARCHITECTURAL AS BUILT
Time Square Business Park
South Salt Lake City, UT 84115

01	100% SUBMISSION	SEE COVER SHEET
NO.	ISSUES REVISIONS	DATE
		SHEET TITLE
HL	PROJECT MANAGER	
HL	PROJECT DIRECTOR	
012317-1	PROJECT NUMBER	
3/32"=1'-0"	SCALE	
CL	DRAWN BY	
		SHEET NUMBER
AB-10		

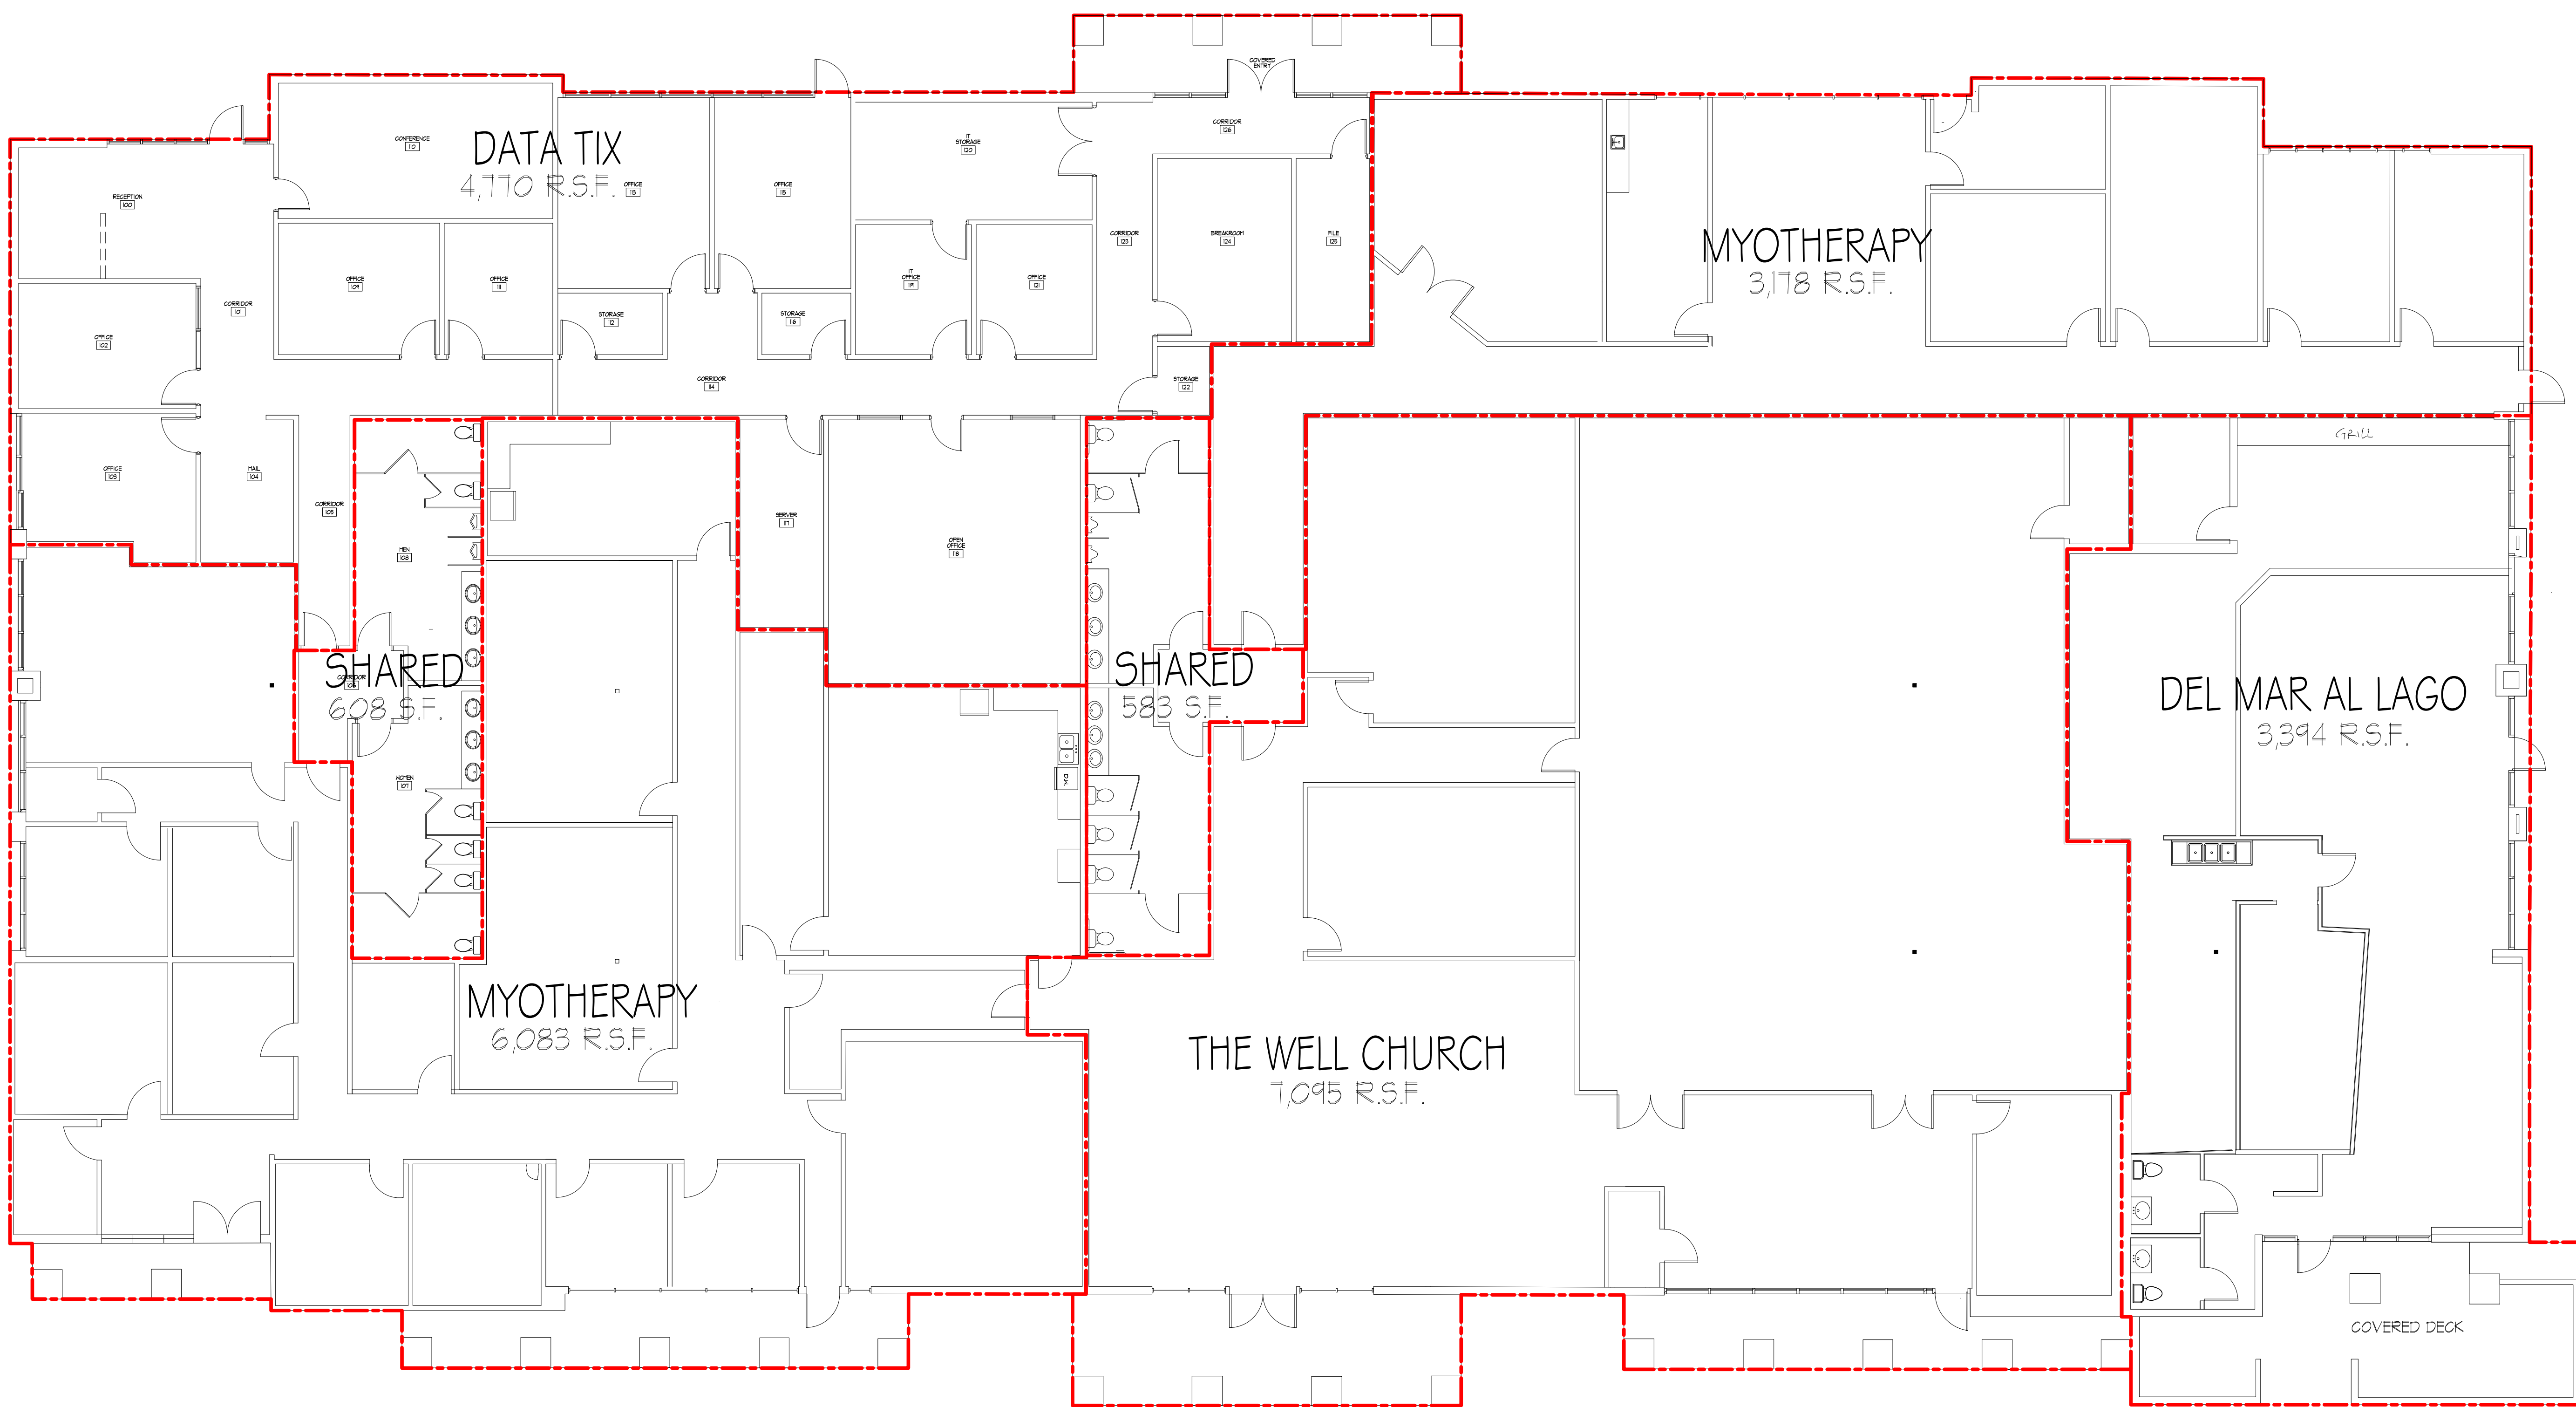

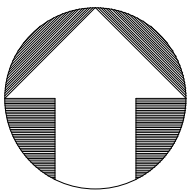BLDG 11 FLOOR PLAN 25,711 RSA (SINGLE TENANT) 



As BUILT
PROFESSIONALS
www.asbuiltprofessionals.com
A DIVISION OF:





AEC
CONSULTANTS INC
844.272.8458
844 ASBUILT


© 2019 AEC CONSULTANTS INC


ARCHITECTURAL AS BUILT
Time Square Business Park
South Salt Lake City, UT 84115

01	100% SUBMISSION	SEE COVER SHEET	
NO.	ISSUES REVISIONS	DATE	
		SHEET TITLE	
HL	PROJECT MANAGER		
HL	PROJECT DIRECTOR		
012317-1	PROJECT NUMBER		
1/8"=1'-0"	SCALE		
CL	DRAWN BY		
		SHEET NUMBER	
AB-11			

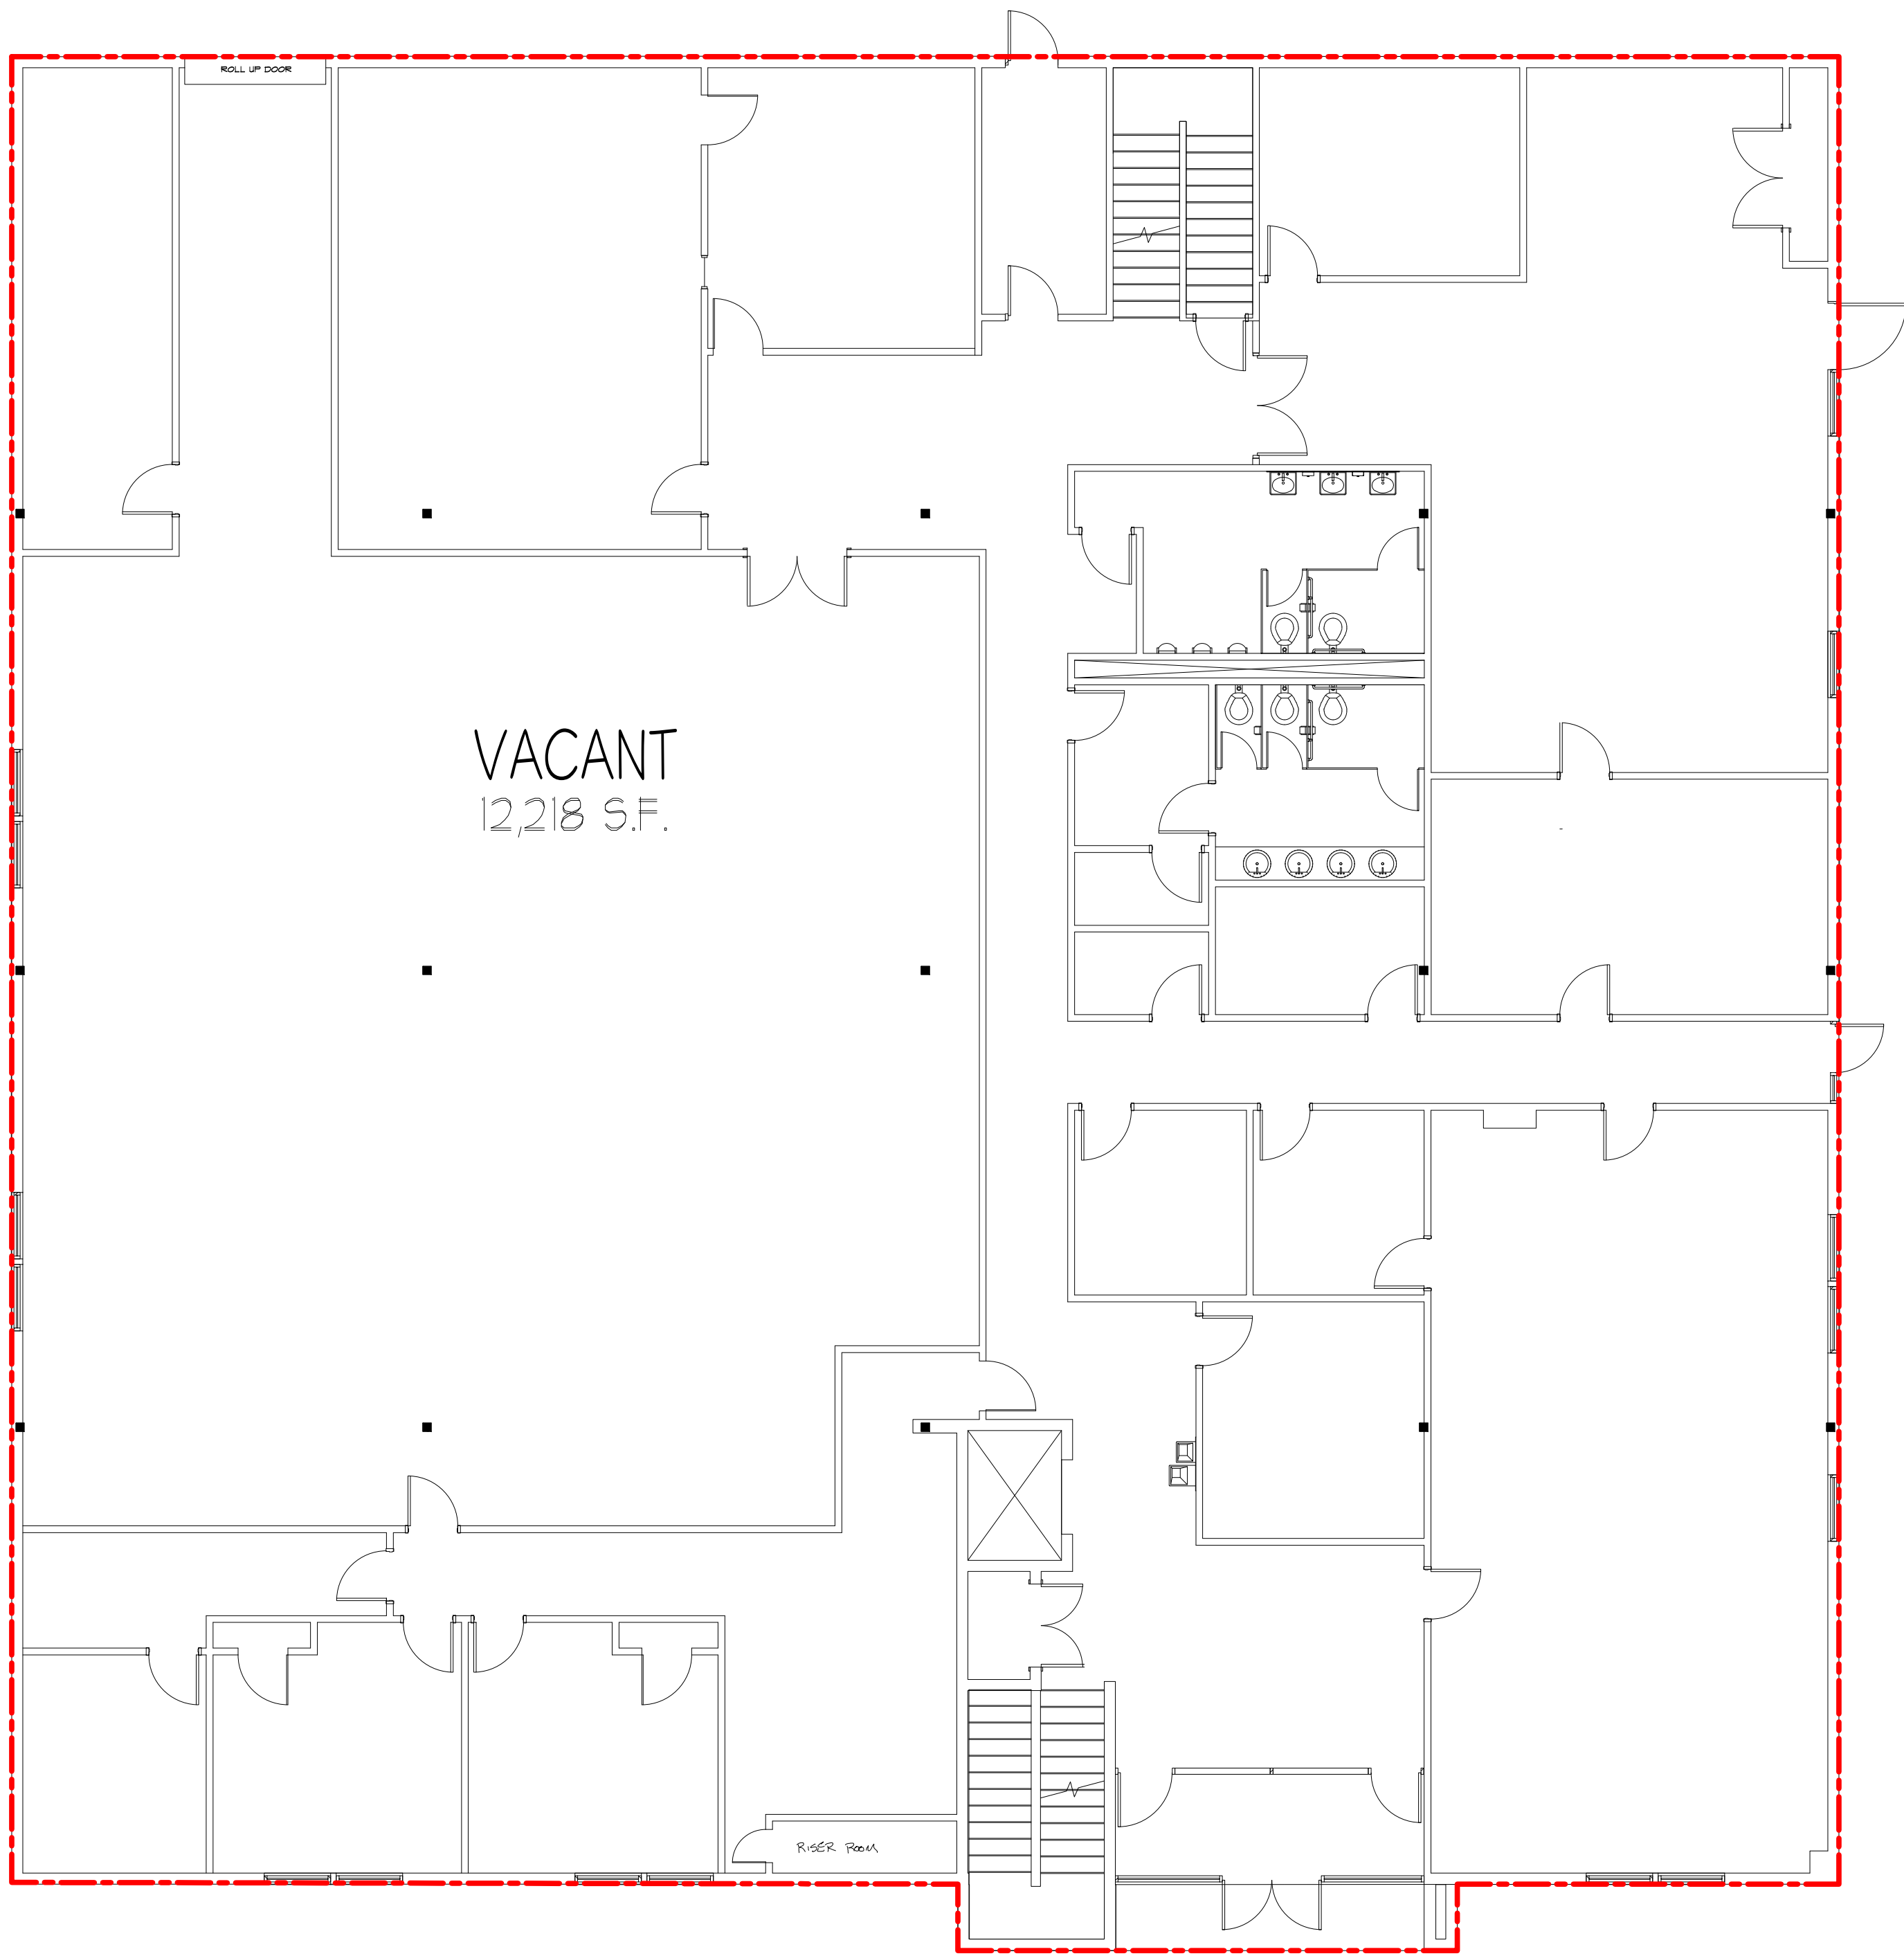

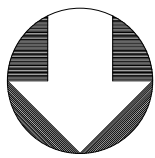BLDG 12 FIRST FLOOR PLAN 12,218 RSA (SINGLE TENANT) 

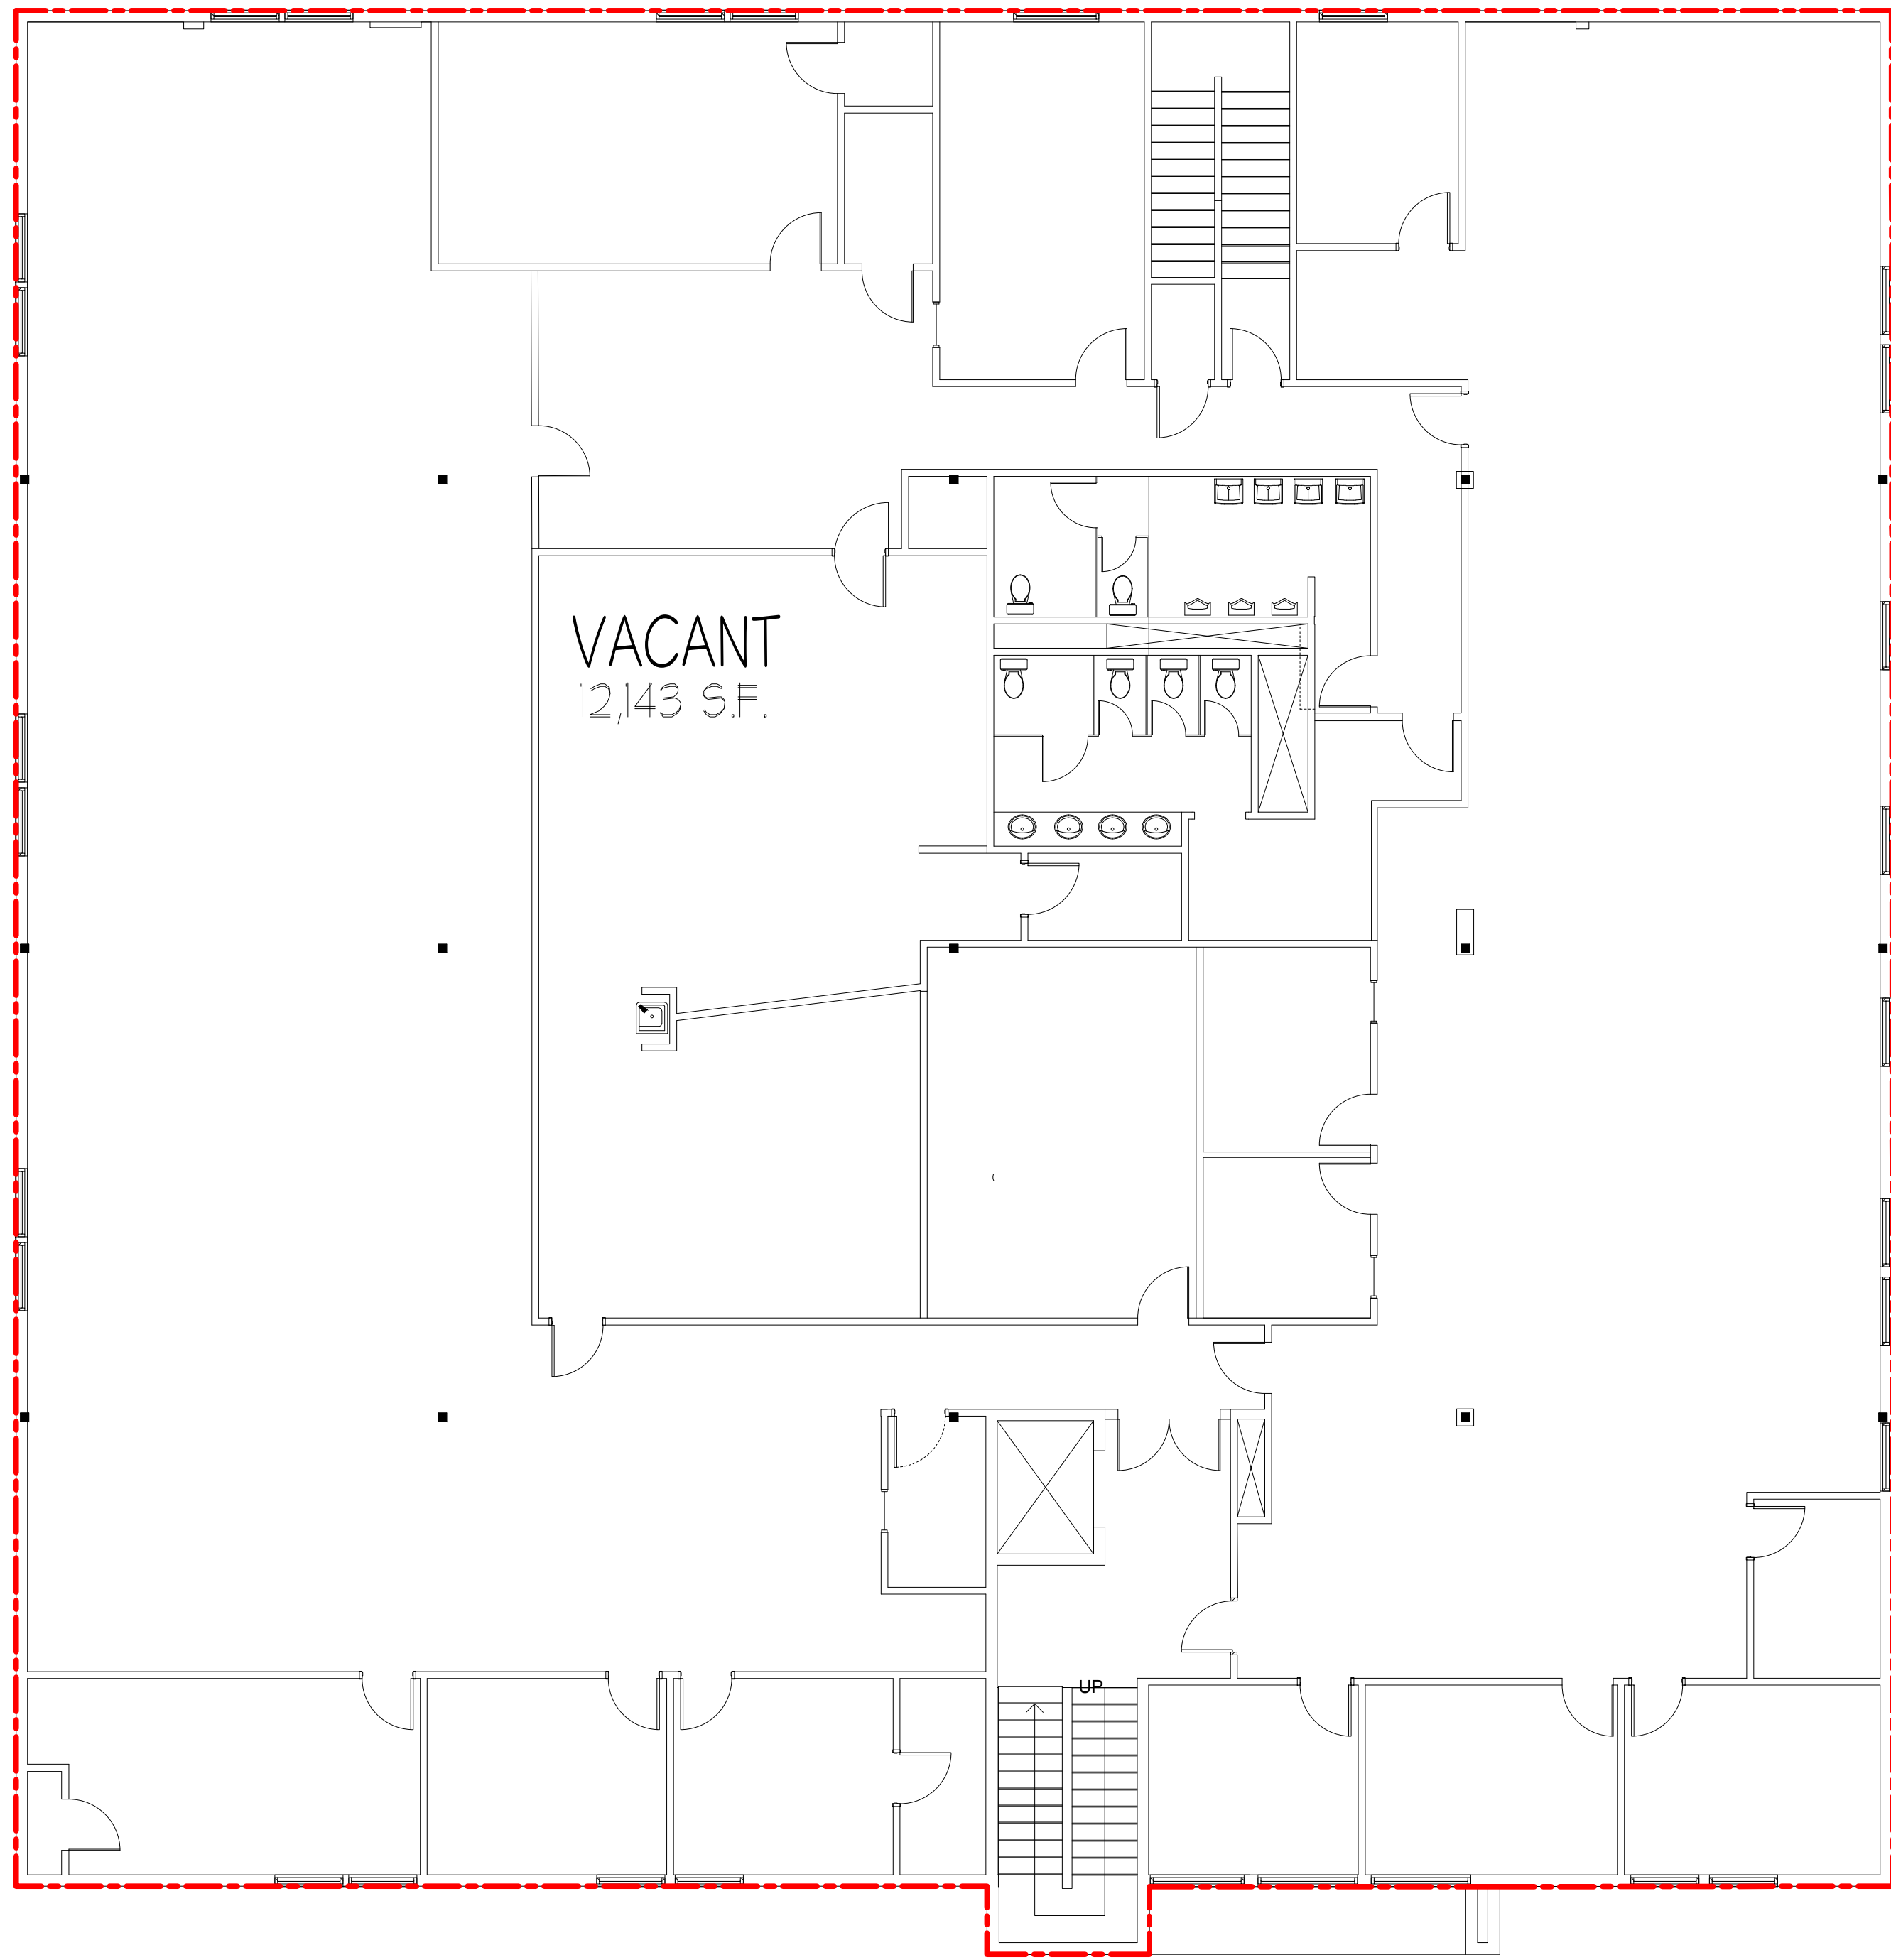

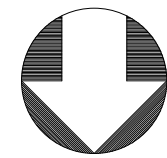BLDG 12 SECOND FLOOR PLAN 12,143 RSA (SINGLE TENANT) 

As BUILT

PROFESSIONALS

www.asbuiltprofessionals.com

A DIVISION OF:

AEC

CONSULTANTS INC

844.272.8458

844 AS BUILT

@ 2019 AEC CONSULTANTS INC

ARCHITECTURAL AS BUILT
Time Square Business Park
South Salt Lake City, UT 84115

01	100% SUBMISSION	SEE COVER SHEET
NO.	ISSUES REVISIONS	DATE
		SHEET TITLE
HL	PROJECT MANAGER	
HL	PROJECT DIRECTOR	
012317-1		PROJECT NUMBER
1/8"=1'-0"		SCALE
CL	DRAWN BY	
		SHEET NUMBER

AB-12