


AS-BUILT DOCUMENTATION

Valley Stream, NY 11581



DRAWING INDEX

- C-1 COVER SHEET | DRAWING INDEX
- SL SYMBOLS LEGEND
- AB-1 BASEMENT PLAN
- AB-2 MAIN LEVEL PLAN
- AB-3 EXTERIOR ELEVATIONS

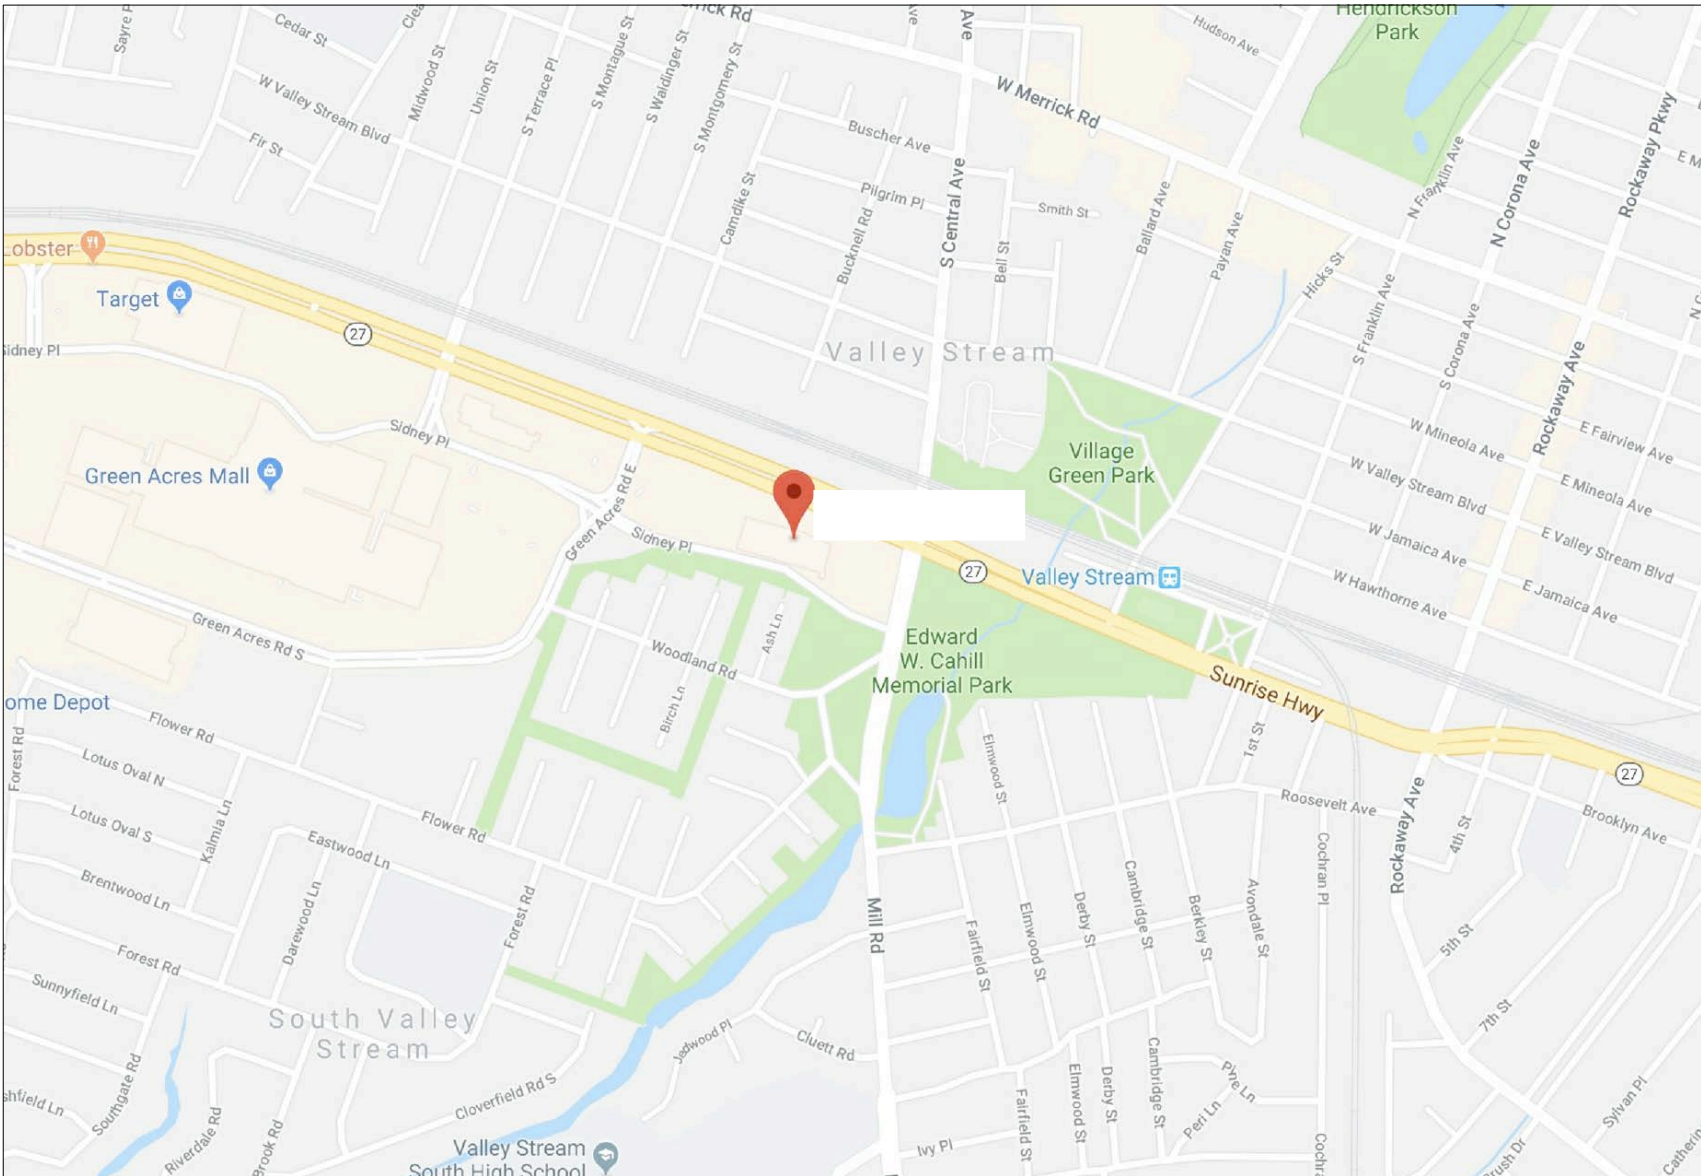

VICINITY MAP

NTS

AREA DATA	
BASEMENT	20,479 S.F. ±
FIRST FLOOR	58,608 S.F. ±
TOTAL CONDITIONED	79,087 S.F. ±
PARKING AREA	28,425 S.F. ±
GRAND TOTAL	107,512 S.F. ±

As BUILT

PROFESSIONALS

www.asbuiltprofessionals.com

A DIVISION OF:

AEC

CONSULTANTS INC

844.272.8458

844 AS BUILT

© 2018 AEC CONSULTANTS, INC.

ARCHITECTURAL AS BUILT

Valley Stream, NY 11581

100% SUBMITTAL

01	100% SUBMISSION	SEE COVER SHEET
NO.	ISSUES REVISIONS	DATE
		SHEET TITLE
COVER SHEET		
HL	PROJECT MANAGER	
HL	PROJECT DIRECTOR	
—	PROJECT NUMBER	
AS NOTED	SCALE	
CL	DRAWN BY	
		SHEET NUMBER
C-1		

 
SYMBOLS LEGEND

NOT TO SCALE


RCP




EXHAUST VENT



CEILING MOUNTED LIGHT FIXTURE

 

CEILING MOUNTED DIRECTIONAL LIGHT

 


RECESSED CAN LIGHT




EYEBALL OR SMALL CAN LIGHT



 
PENDANT LIGHT



INDIVIDUAL FLUOR. LAY-IN FIXTURE 4 BULB

 

 INDIVIDUAL FLUOR. HANGING FIXTURE 2 BULB




INDIVIDUAL FLUOR. FLUSH MOUNT FIXTURE 4 BULB



CAMERA



 MOTION DET.




SUPPLY VENT




SUPPLY VENT



 
RETURN VENT




RETURN VENT

 


SPEAKER

 


TRACK LIGHT OR VANITY LIGHT

 


WALL-MOUNTED LIGHT FIXTURE

 


EMERGENCY EXIT SIGN

 


EMERGENCY EXIT LIGHT

 

EMERGENCY EXIT LIGHT W/ SIGN

 

LIGHTED STAIR SIGN

 

FLOOD LIGHT

 


PHOTO CELL



 
CEILING FAN



CEILING FAN W/ LIGHT KIT

7-2-6

CEILING HEIGHT AND TRIM 7'-2" ABOVE FLOOR BELOW WITH 6" CROWN MOULDING. NOTE: ALL CEILINGS NOT LABELED ARE PLASTER. CEILINGS SHOWN WITH A GRID ARE LAY IN ACOUSTICAL TILE..



JUNCTION BOX

ELECTRIC



DATA OUTLET



TELEPHONE JACK



ELECTRIC SWITCH



CABLE TELEVISION OUTLET



DUPLEX RECEPTACLE OUTLET



 
SPECIAL PURPOSE CONNECTION OR OUTLET



QUADRUPLEX RECEPTACLE OUTLET



FLOOR DUPLEX RECEPTACLE OUTLET



ELECTRIC PANEL



ELECTRIC METER



BUTTON SWITCH



DISCONNECT SWITCH



GROUND/FLOOR LIGHT



KEY PAD

FIRE PROTECTION



FIRE EXTINGUISHER



 
FIRE PULL



FIRE ALARM (HORN/SRTOBE)



SMOKE DETECTOR



SMOKE ALARM SPEAKER



SPRINKLER HEAD CEILING MOUNT



SPRINKLER HEAD WALL MOUNT

MEP



THERMOSTAT



FLOOR DRAIN



VALVE



HOSE BIB



WATER SUPPLY



SUSPENDED GAS HEATER


MISC




BOLLARD




SPOT ELEVATION

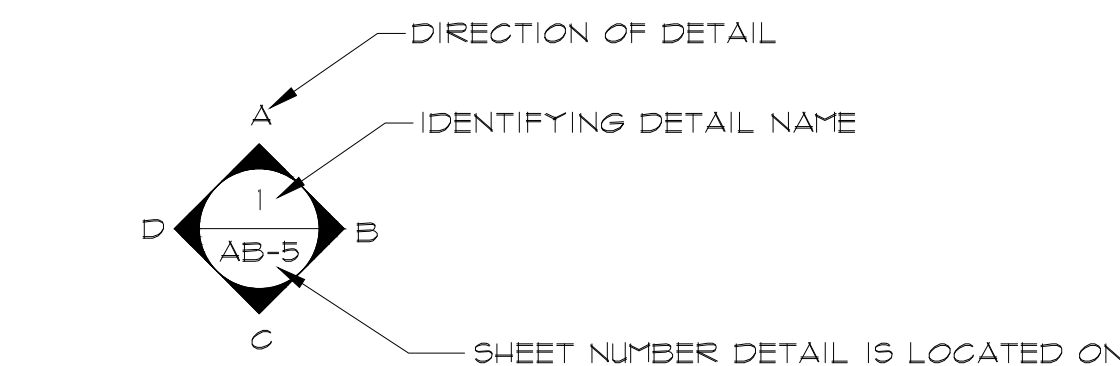

INTERIOR ELEVATIONS

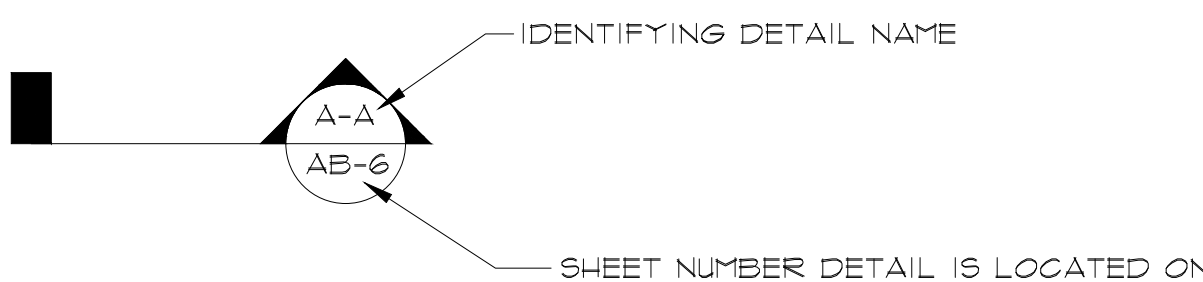

BUILDING SECTION

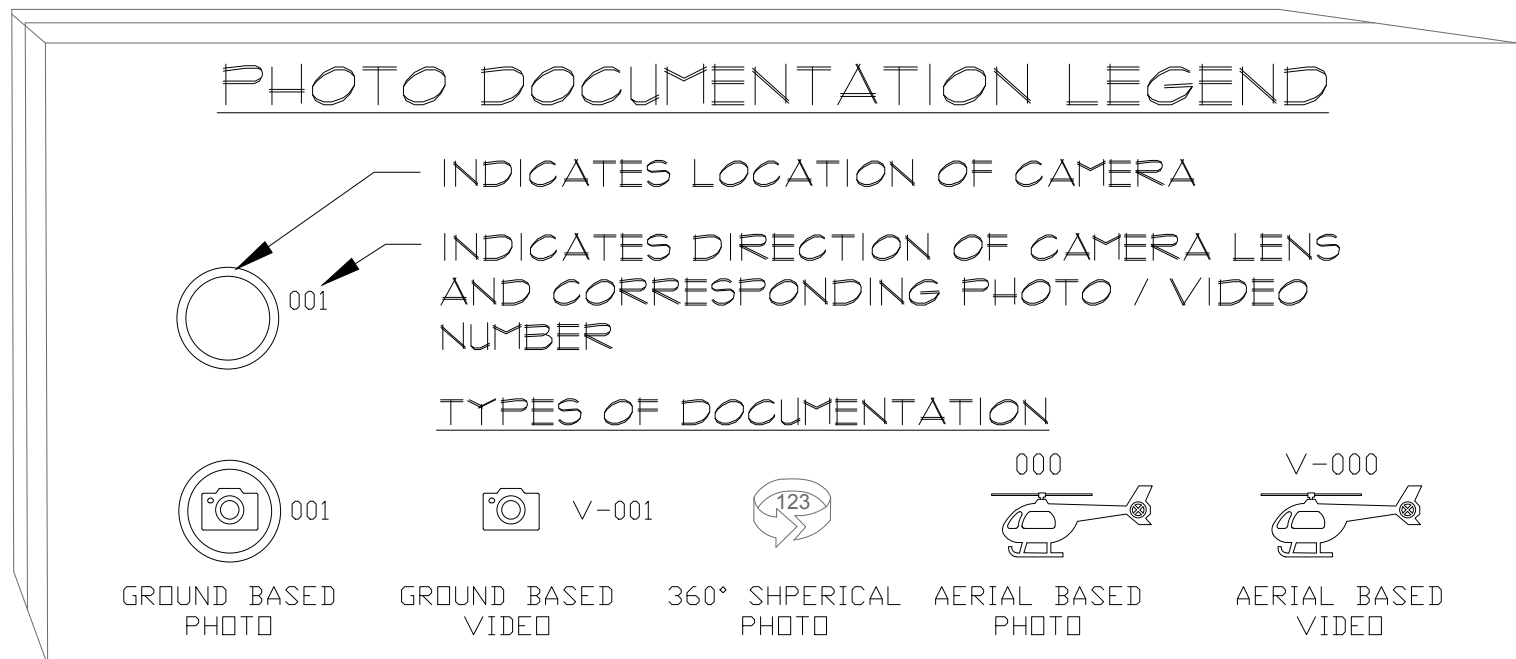

As BUILT
PROFESSIONALS
www.asbuiltprofessionals.com
A DIVISION OF:



© 2018 AEC CONSULTANTS INC.

ARCHITECTURAL AS BUILT

Valley Stream, NY 11581


01	100% SUBMISSION	SEE COVER SHEET
NO.	ISSUES REVISIONS	DATE
SHEET TITLE		

HL	PROJECT MANAGER
HL	PROJECT DIRECTOR
-	PROJECT NUMBER
AS NOTED	SCALE
CL	DRAWN BY
	SHEET NUMBER

SL


ARCHITECTURAL AS BUILT

Valley Stream, NY 11581

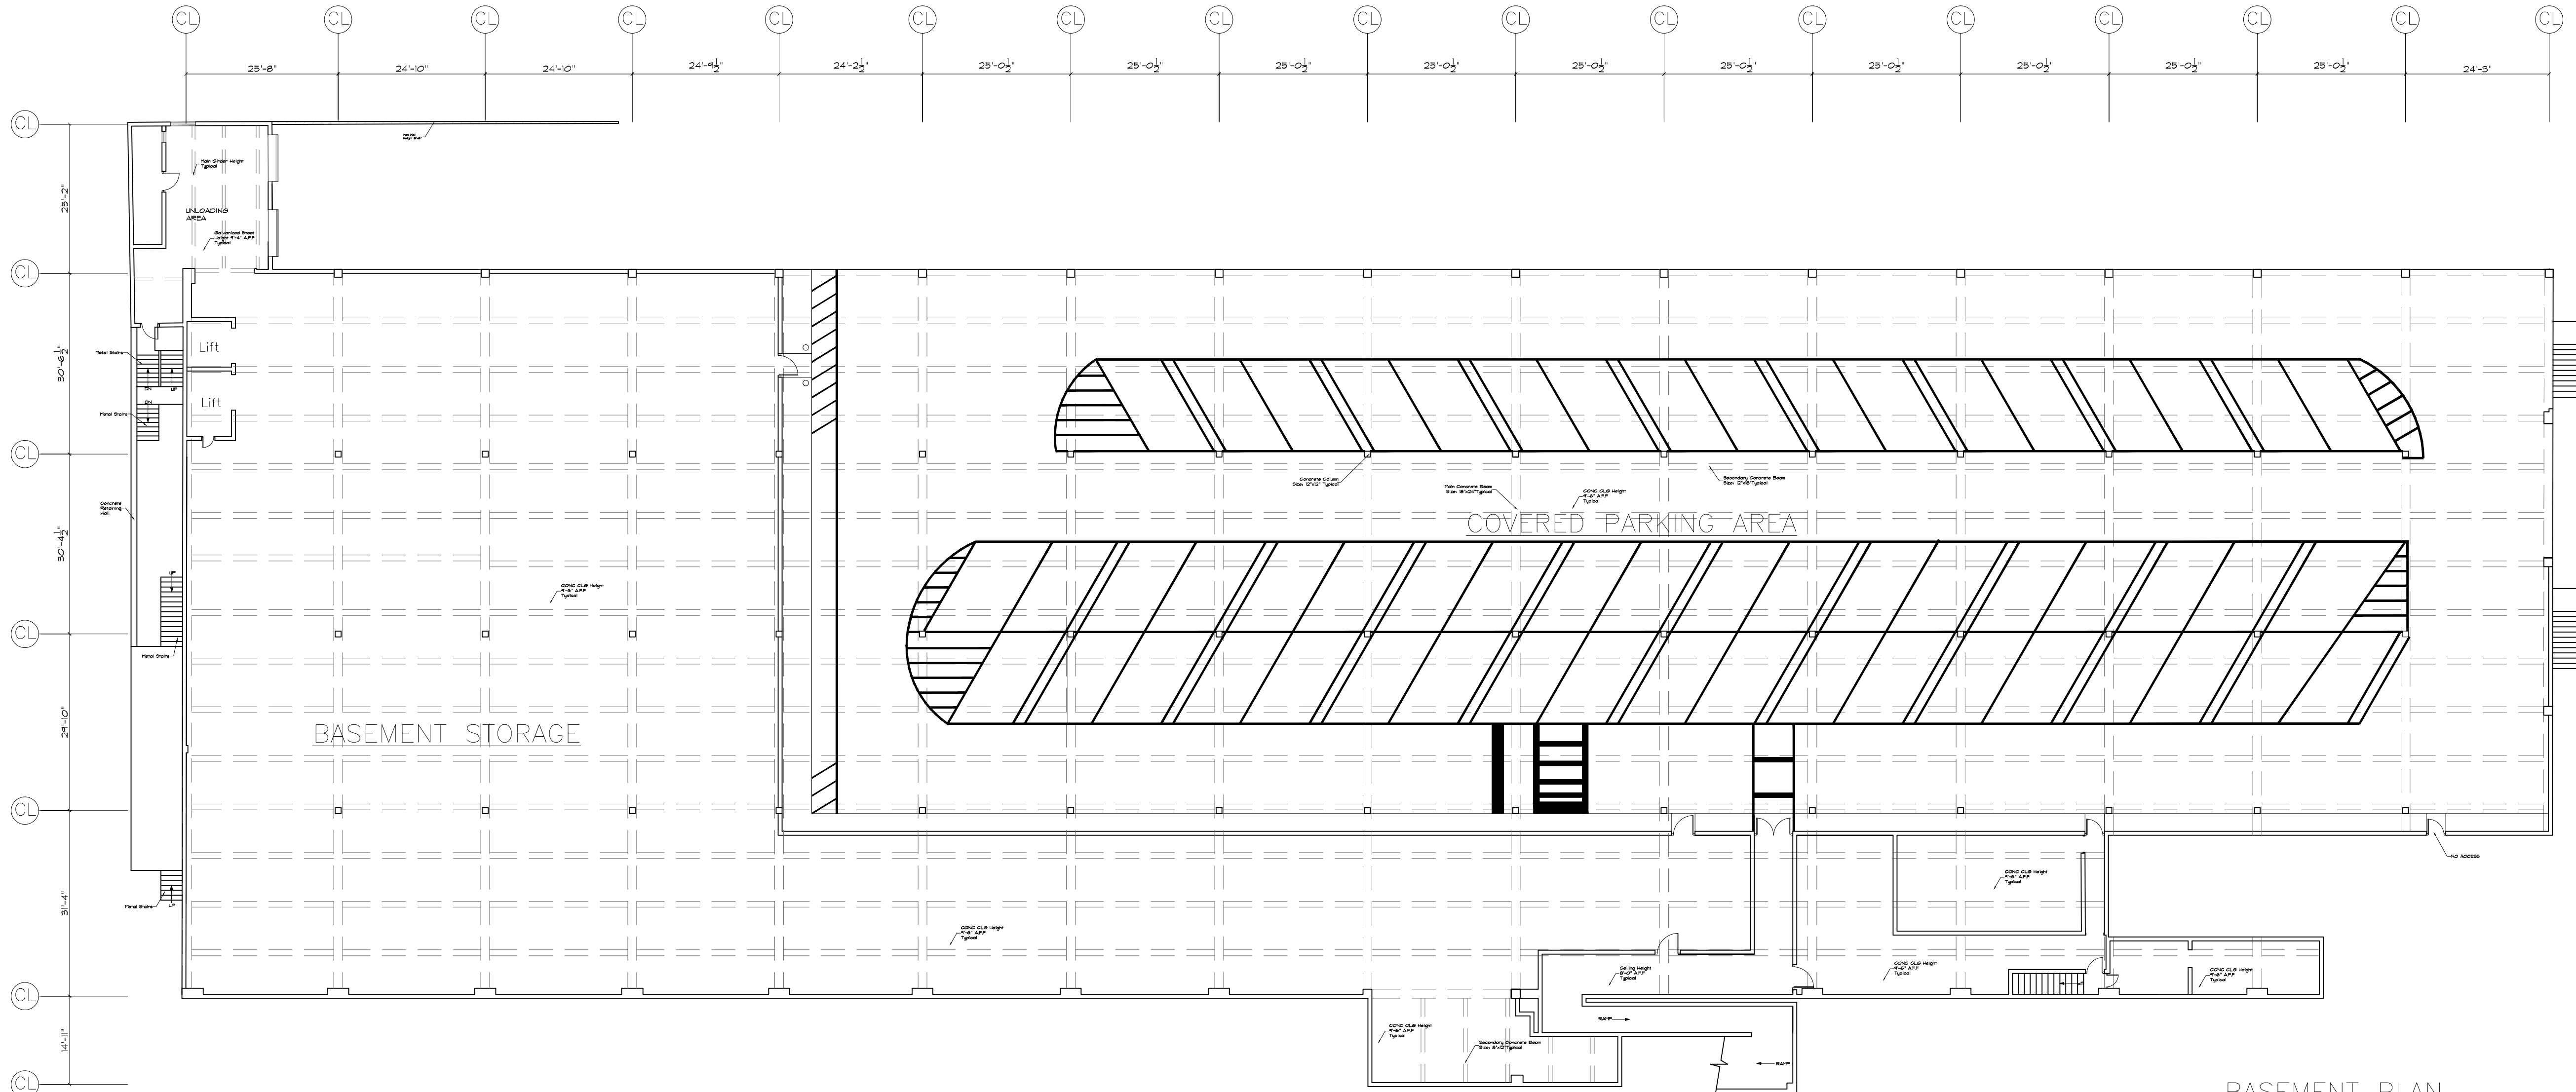

BASEMENT PLAN
SCALE 1/16" = 1'-0"

01	100% SUBMISSION	SEE COVER SHEET
NO.	ISSUES REVISIONS	DATE
		SHEET TITLE
HL		PROJECT MANAGER
HL		PROJECT DIRECTOR
—		PROJECT NUMBER
AS NOTED		SCALE
CL		DRAWN BY
		SHEET NUMBER

 

Valley Stream, NY 11581

01	100% SUBMISSION	SEE COVER SHEET
NO.	ISSUES REVISIONS	DATE
		SHEET TITLE
HL	PROJECT MANAGER	
HL	PROJECT DIRECTOR	
—	PROJECT NUMBER	
AS NOTED	SCALE	
CL	DRAWN BY	
	SHEET NUMBER	
<div>AB-2</div>		

As BUILT

PROFESSIONALS

www.asbuiltprofessionals.com

A DIVISION OF:

AEC

CONSULTANTS INC

844.272.8458

844 AS BUILT


© 2018 AEC CONSULTANTS INC

ARCHITECTURAL AS BUILT


Valley Stream, NY 11581

01	100% SUBMISSION	SEE COVER SHEET
NO.	ISSUES REVISIONS	DATE
		SHEET TITLE
HL		PROJECT MANAGER
HL		PROJECT DIRECTOR
-		PROJECT NUMBER
AS NOTED		SCALE
CL		DRAWN BY
		SHEET NUMBER


AB-3

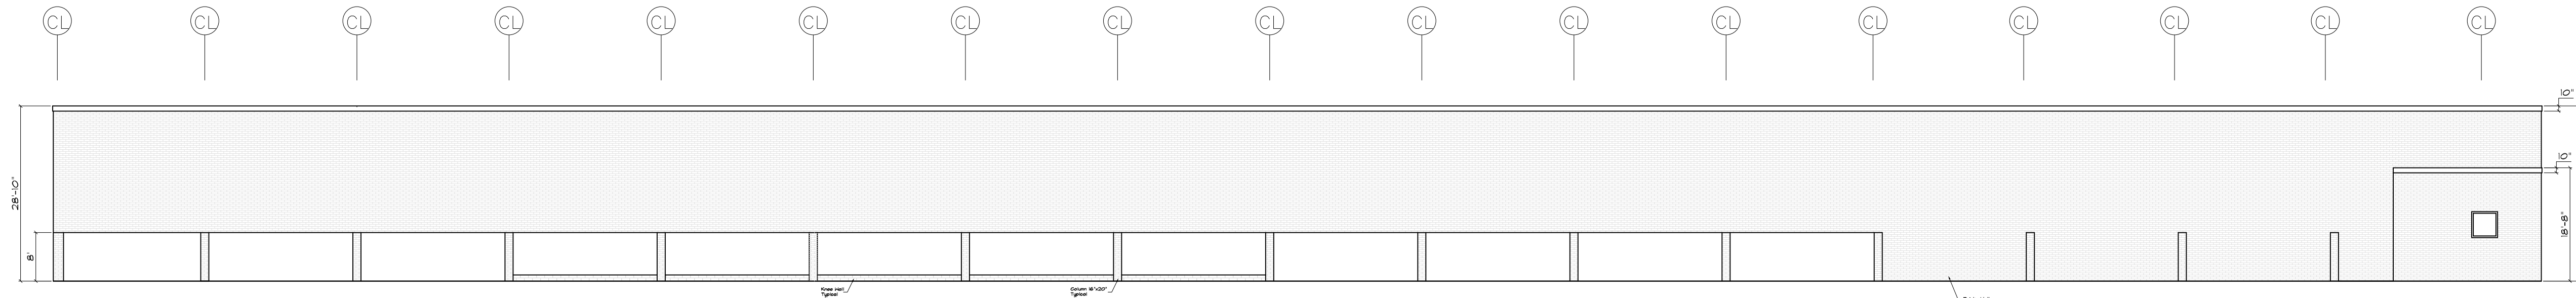


REAR ELEVATION
SCALE 1/16" = 1'-0"

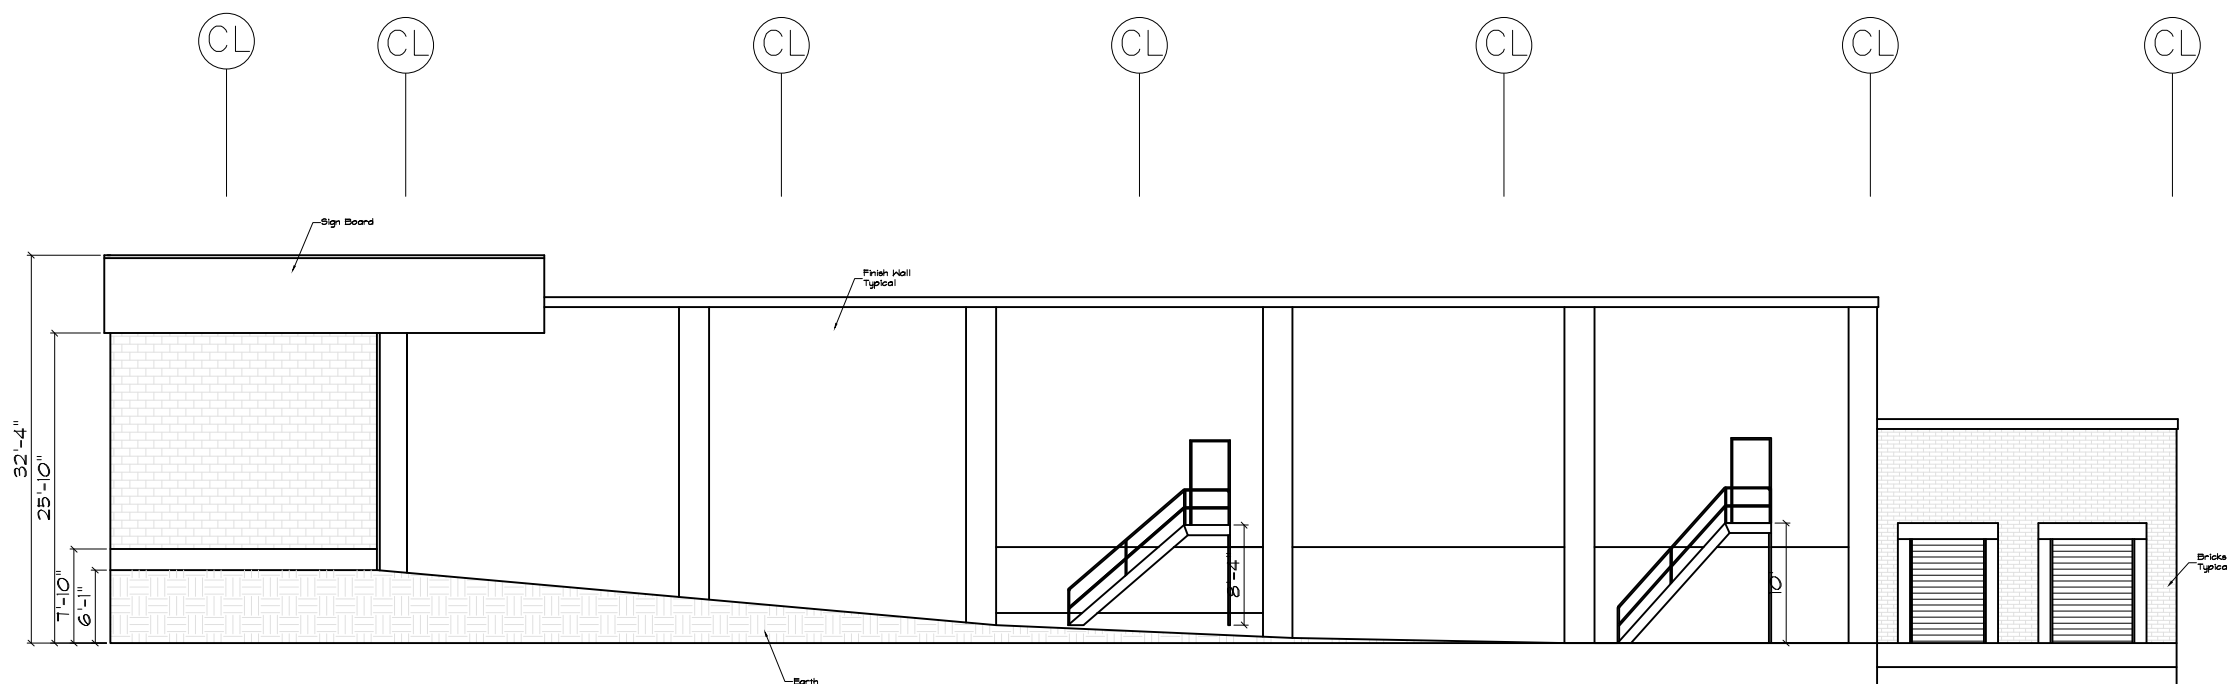

LEFT SIDE ELEVATION
SCALE 1/16" = 1'-0"

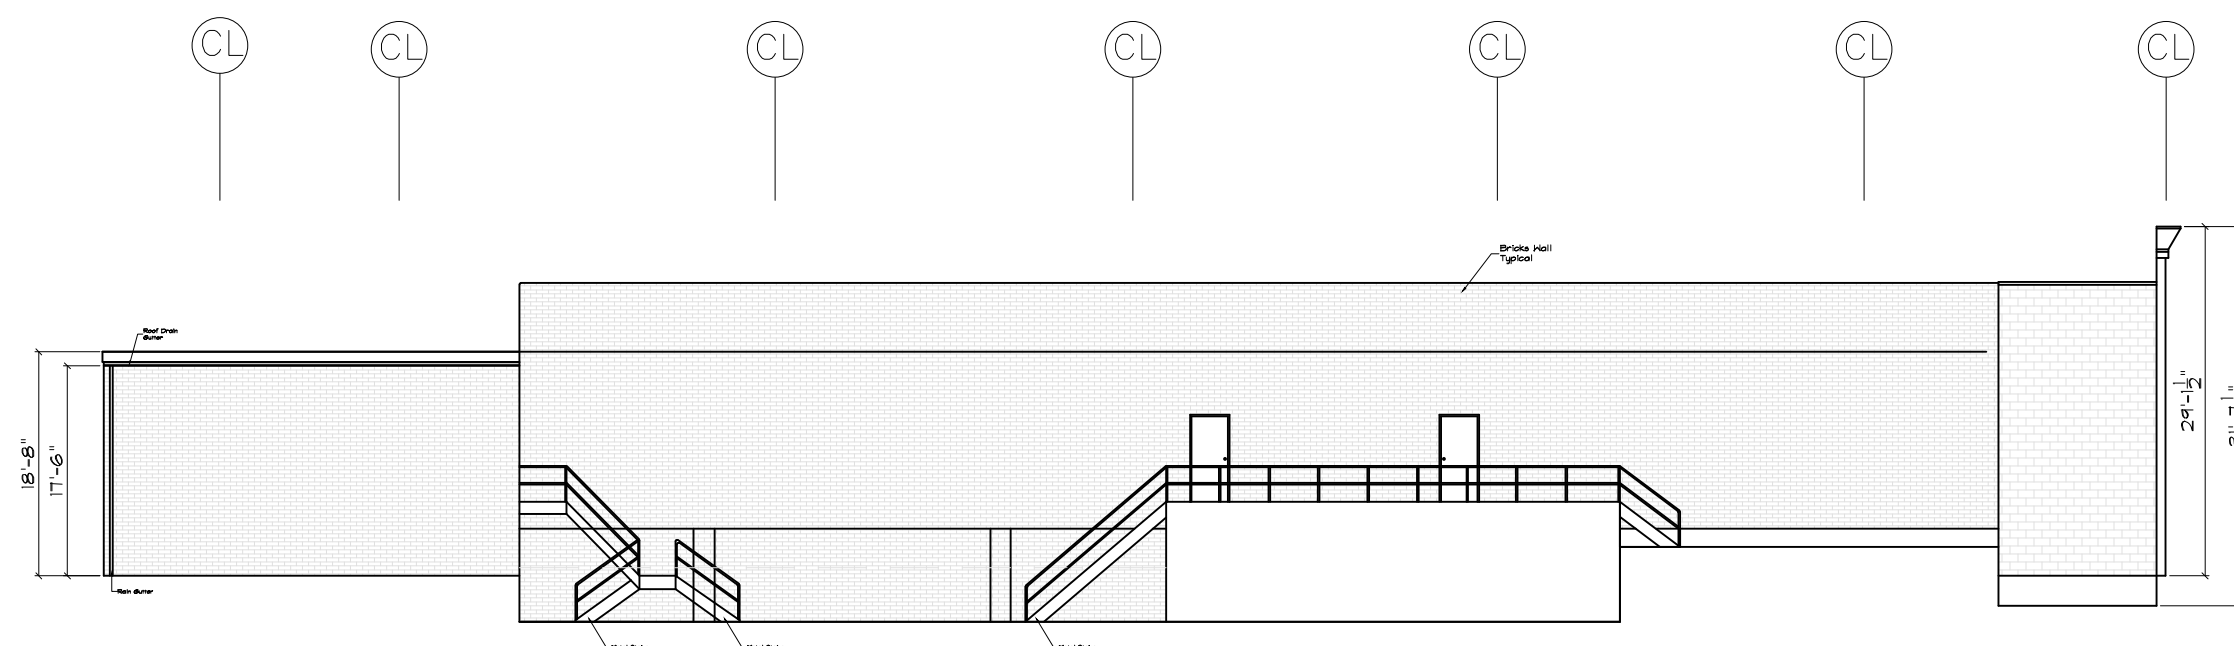

RIGHT SIDE ELEVATION
SCALE 1/16" = 1'-0"

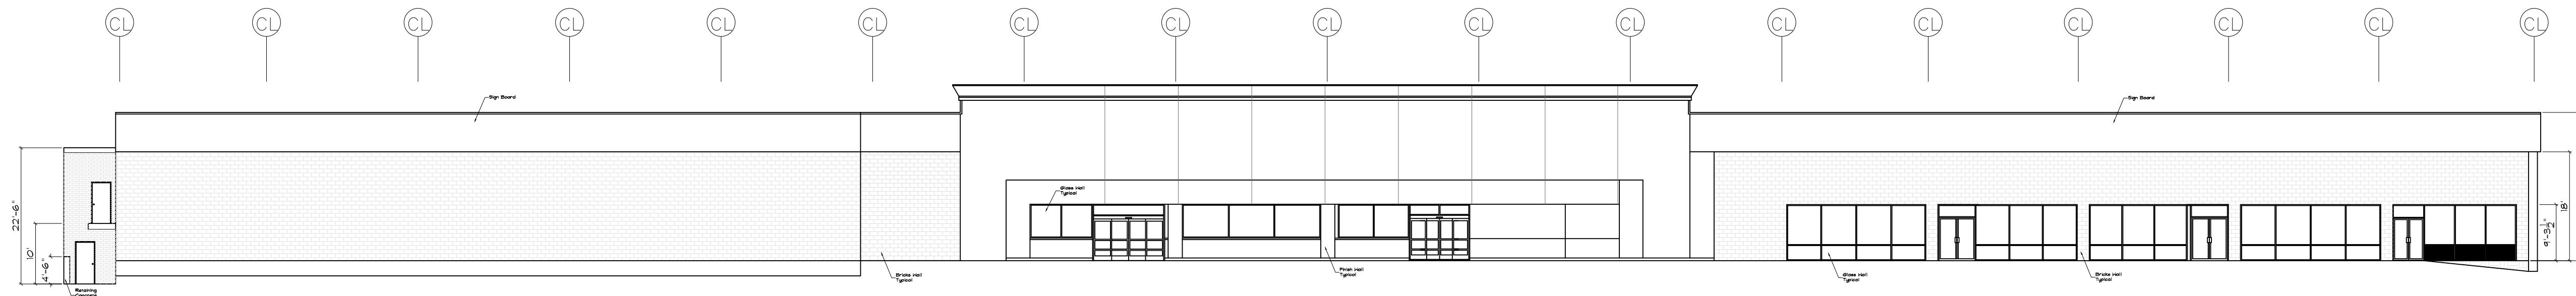

FRONT ELEVATION
SCALE 1/16" = 1'-0"