

AS-BUILT DOCUMENTATION


Danbury, CT 06810



100% SUBMITTAL

DRAWING INDEX

- C-1 COVER SHEET | DRAWING INDEX
- SL SYMBOLS LEGEND
- AB-1 FLOOR PLAN
- AB-2 EXTERIOR ELEVATIONS

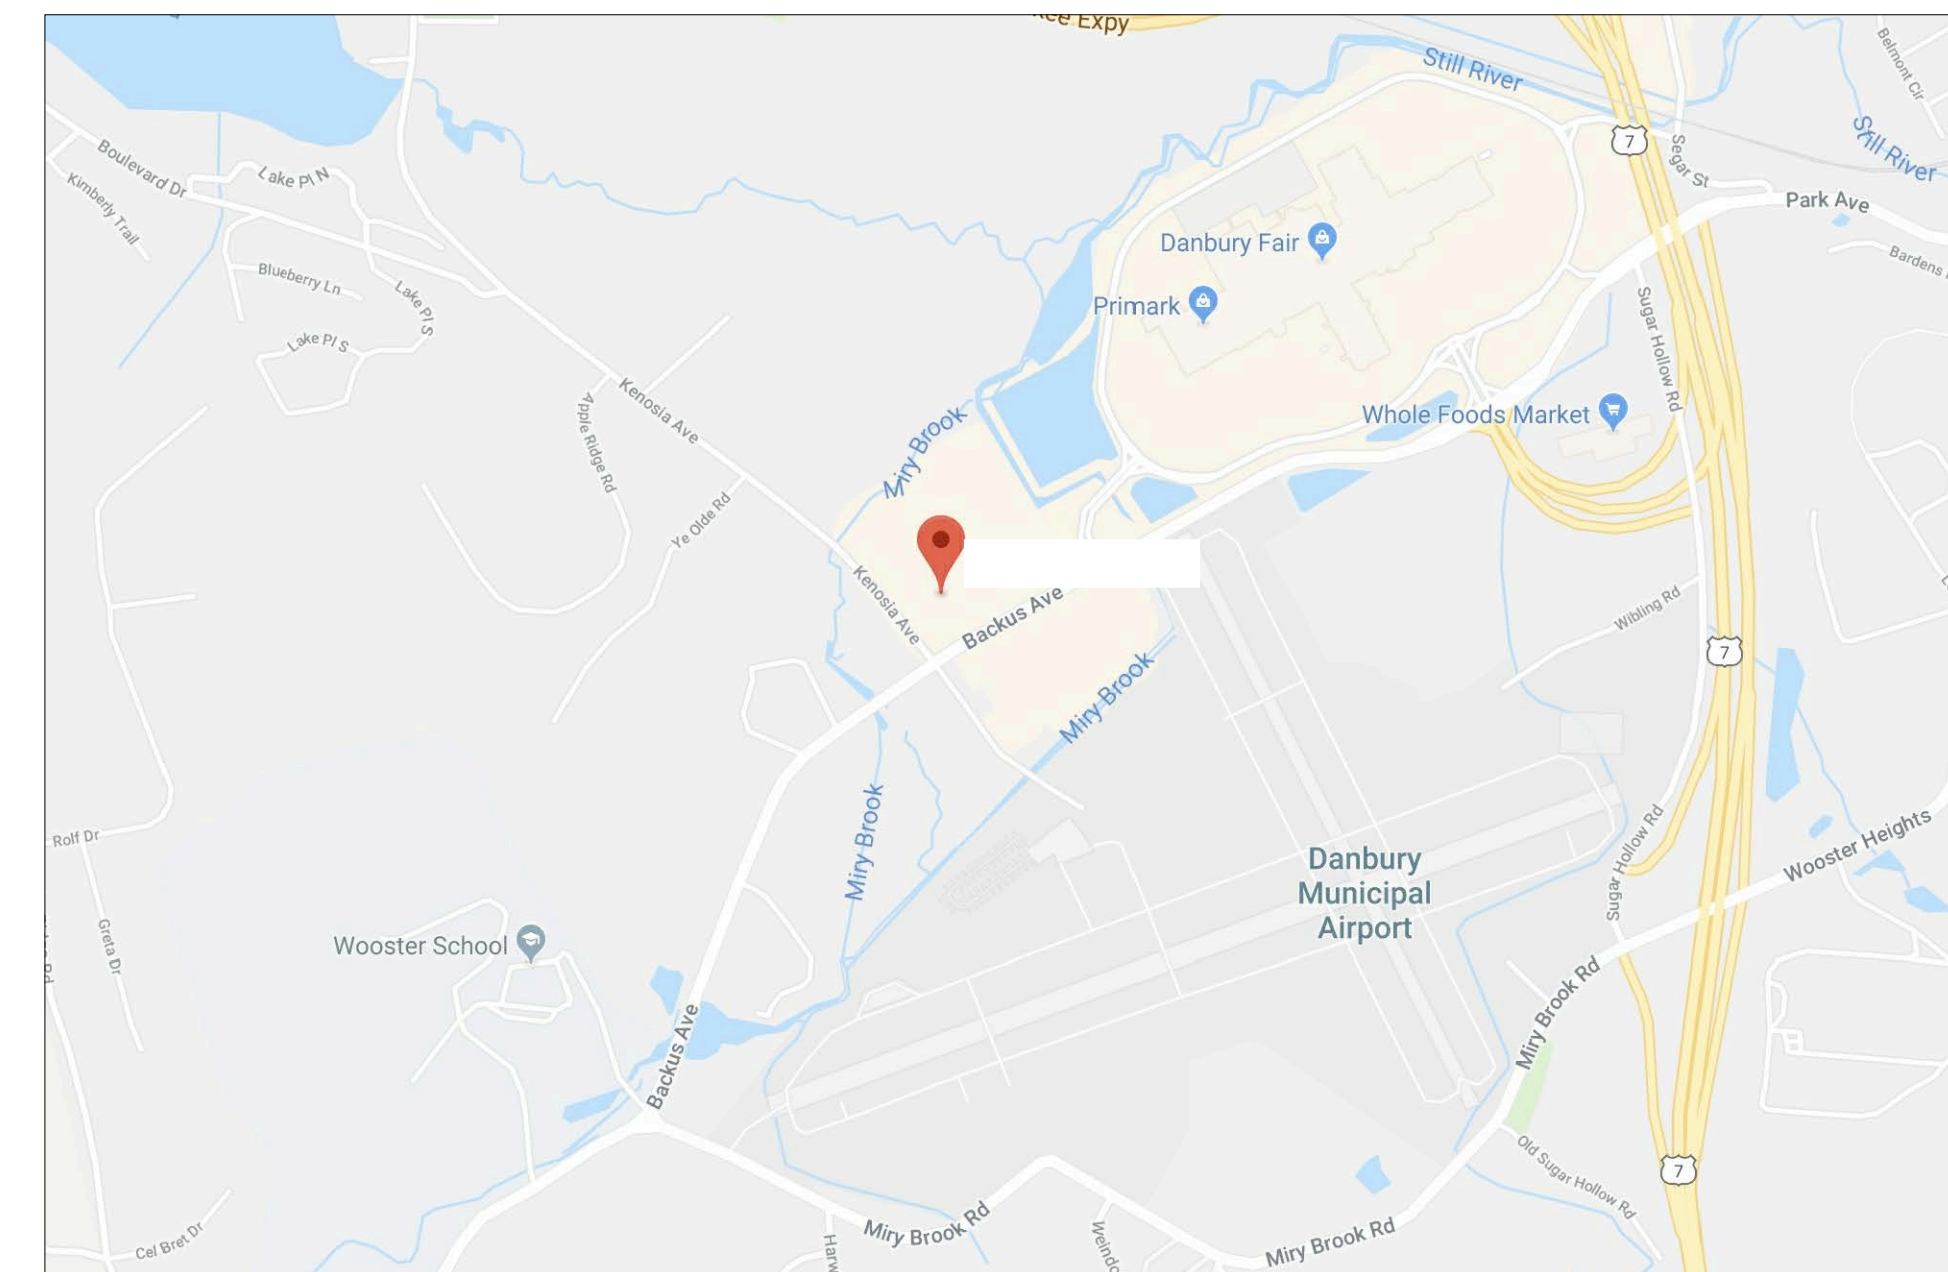

VICINITY MAP
NTS

AREA DATA	
CONDITIONED SPACE	66,023 S.F. ±



ARCHITECTURAL AS BUILT

Danbury, CT 06810

01	100% SUBMISSION	SEE COVER SHEET
NO.	ISSUES REVISIONS	DATE
SHEET TITLE		

COVER SHEET

HL	PROJECT MANAGER
HL	PROJECT DIRECTOR
-	PROJECT NUMBER
AS NOTED	SCALE
CL	DRAWN BY
	SHEET NUMBER

C-1

SYMBOLS LEGEND

NOT TO SCALE

RCP

	EXHAUST VENT		TRACK LIGHT OR VANITY LIGHT
	CEILING MOUNTED LIGHT FIXTURE		WALL-MOUNTED LIGHT FIXTURE
	CEILING MOUNTED DIRECTIONAL LIGHT		EMERGENCY EXIT SIGN
	RECESSED CAN LIGHT		EMERGENCY EXIT LIGHT
	EYEBALL OR SMALL CAN LIGHT		EMERGENCY EXIT LIGHT W/ SIGN
	PENDANT LIGHT		LIGHTED STAIR SIGN
	INDIVIDUAL FLUOR. LAY-IN FIXTURE 4 BULB		FLOOD LIGHT
	INDIVIDUAL FLUOR. HANGING FIXTURE 2 BULB		PHOTO CELL
	INDIVIDUAL FLUOR. FLUSH MOUNT FIXTURE 4 BULB		CEILING FAN
	CAMERA		CEILING FAN W/ LIGHT KIT
	MOTION DET.		
	SUPPLY VENT		
	SUPPLY VENT		
	RETURN VENT		
	RETURN VENT		
	SPEAKER		

7-2-6
 CEILING HEIGHT AND TRIM 1'-2" ABOVE FLOOR BELOW WITH 6" CROWN MOULDING.
 NOTE: ALL CEILINGS NOT LABELED ARE PLASTER. CEILINGS SHOWN WITH A GRID ARE LAY IN ACOUSTICAL TILE..

ELECTRIC

	DATA OUTLET
	TELEPHONE JACK
	ELECTRIC SWITCH
	CABLE TELEVISION OUTLET
	DUPLEX RECEPTACLE OUTLET
	SPECIAL PURPOSE CONNECTION OR OUTLET
	QUADRUPLEX RECEPTACLE OUTLET
	FLOOR DUPLEX RECEPTACLE OUTLET
	ELECTRIC PANEL
	ELECTRIC METER
	BUTTON SWITCH
	DISCONNECT SWITCH
	GROUND/FLOOR LIGHT
	KEY PAD

FIRE PROTECTION


	FIRE EXTINGUISHER
	FIRE PULL
	FIRE ALARM (HORN/SRTOBE)
	SMOKE DETECTOR
	SMOKE ALARM SPEAKER
	SPRINKLER HEAD CEILING MOUNT
	SPRINKLER HEAD WALL MOUNT

MEP


	THERMOSTAT
	FLOOR DRAIN
	VALVE
	HOSE BIB
	WATER SUPPLY
	SUSPENDED GAS HEATER

MISC


	BOLLARD
	11-4-11/16 SPOT ELEVATION

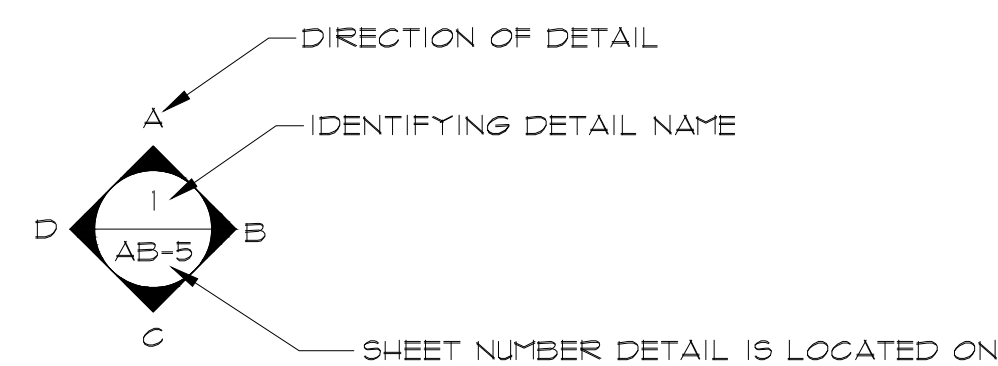

INTERIOR ELEVATIONS

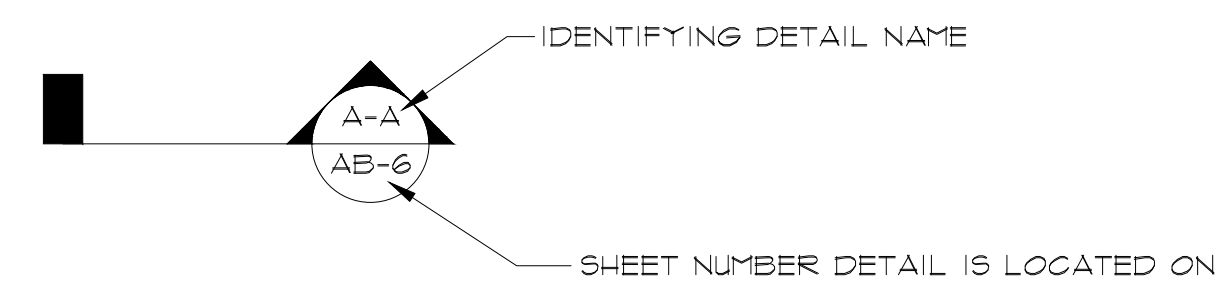

BUILDING SECTION

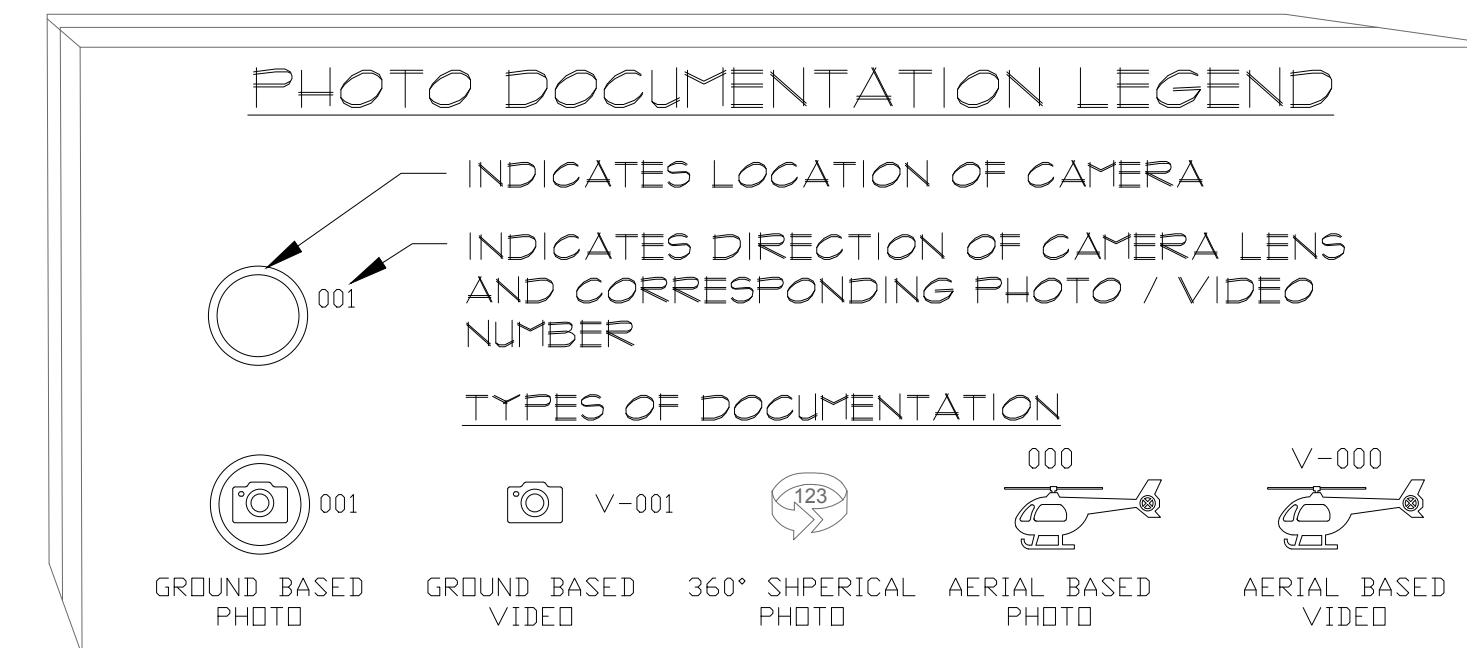


ARCHITECTURAL AS BUILT

Danbury, CT 06810

01	100% SUBMISSION	SEE COVER SHEET
NO.	ISSUES REVISIONS	DATE
SHEET TITLE		

HL	PROJECT MANAGER
HL	PROJECT DIRECTOR
-	PROJECT NUMBER
AS NOTED	SCALE
CL	DRAWN BY
	SHEET NUMBER

SL

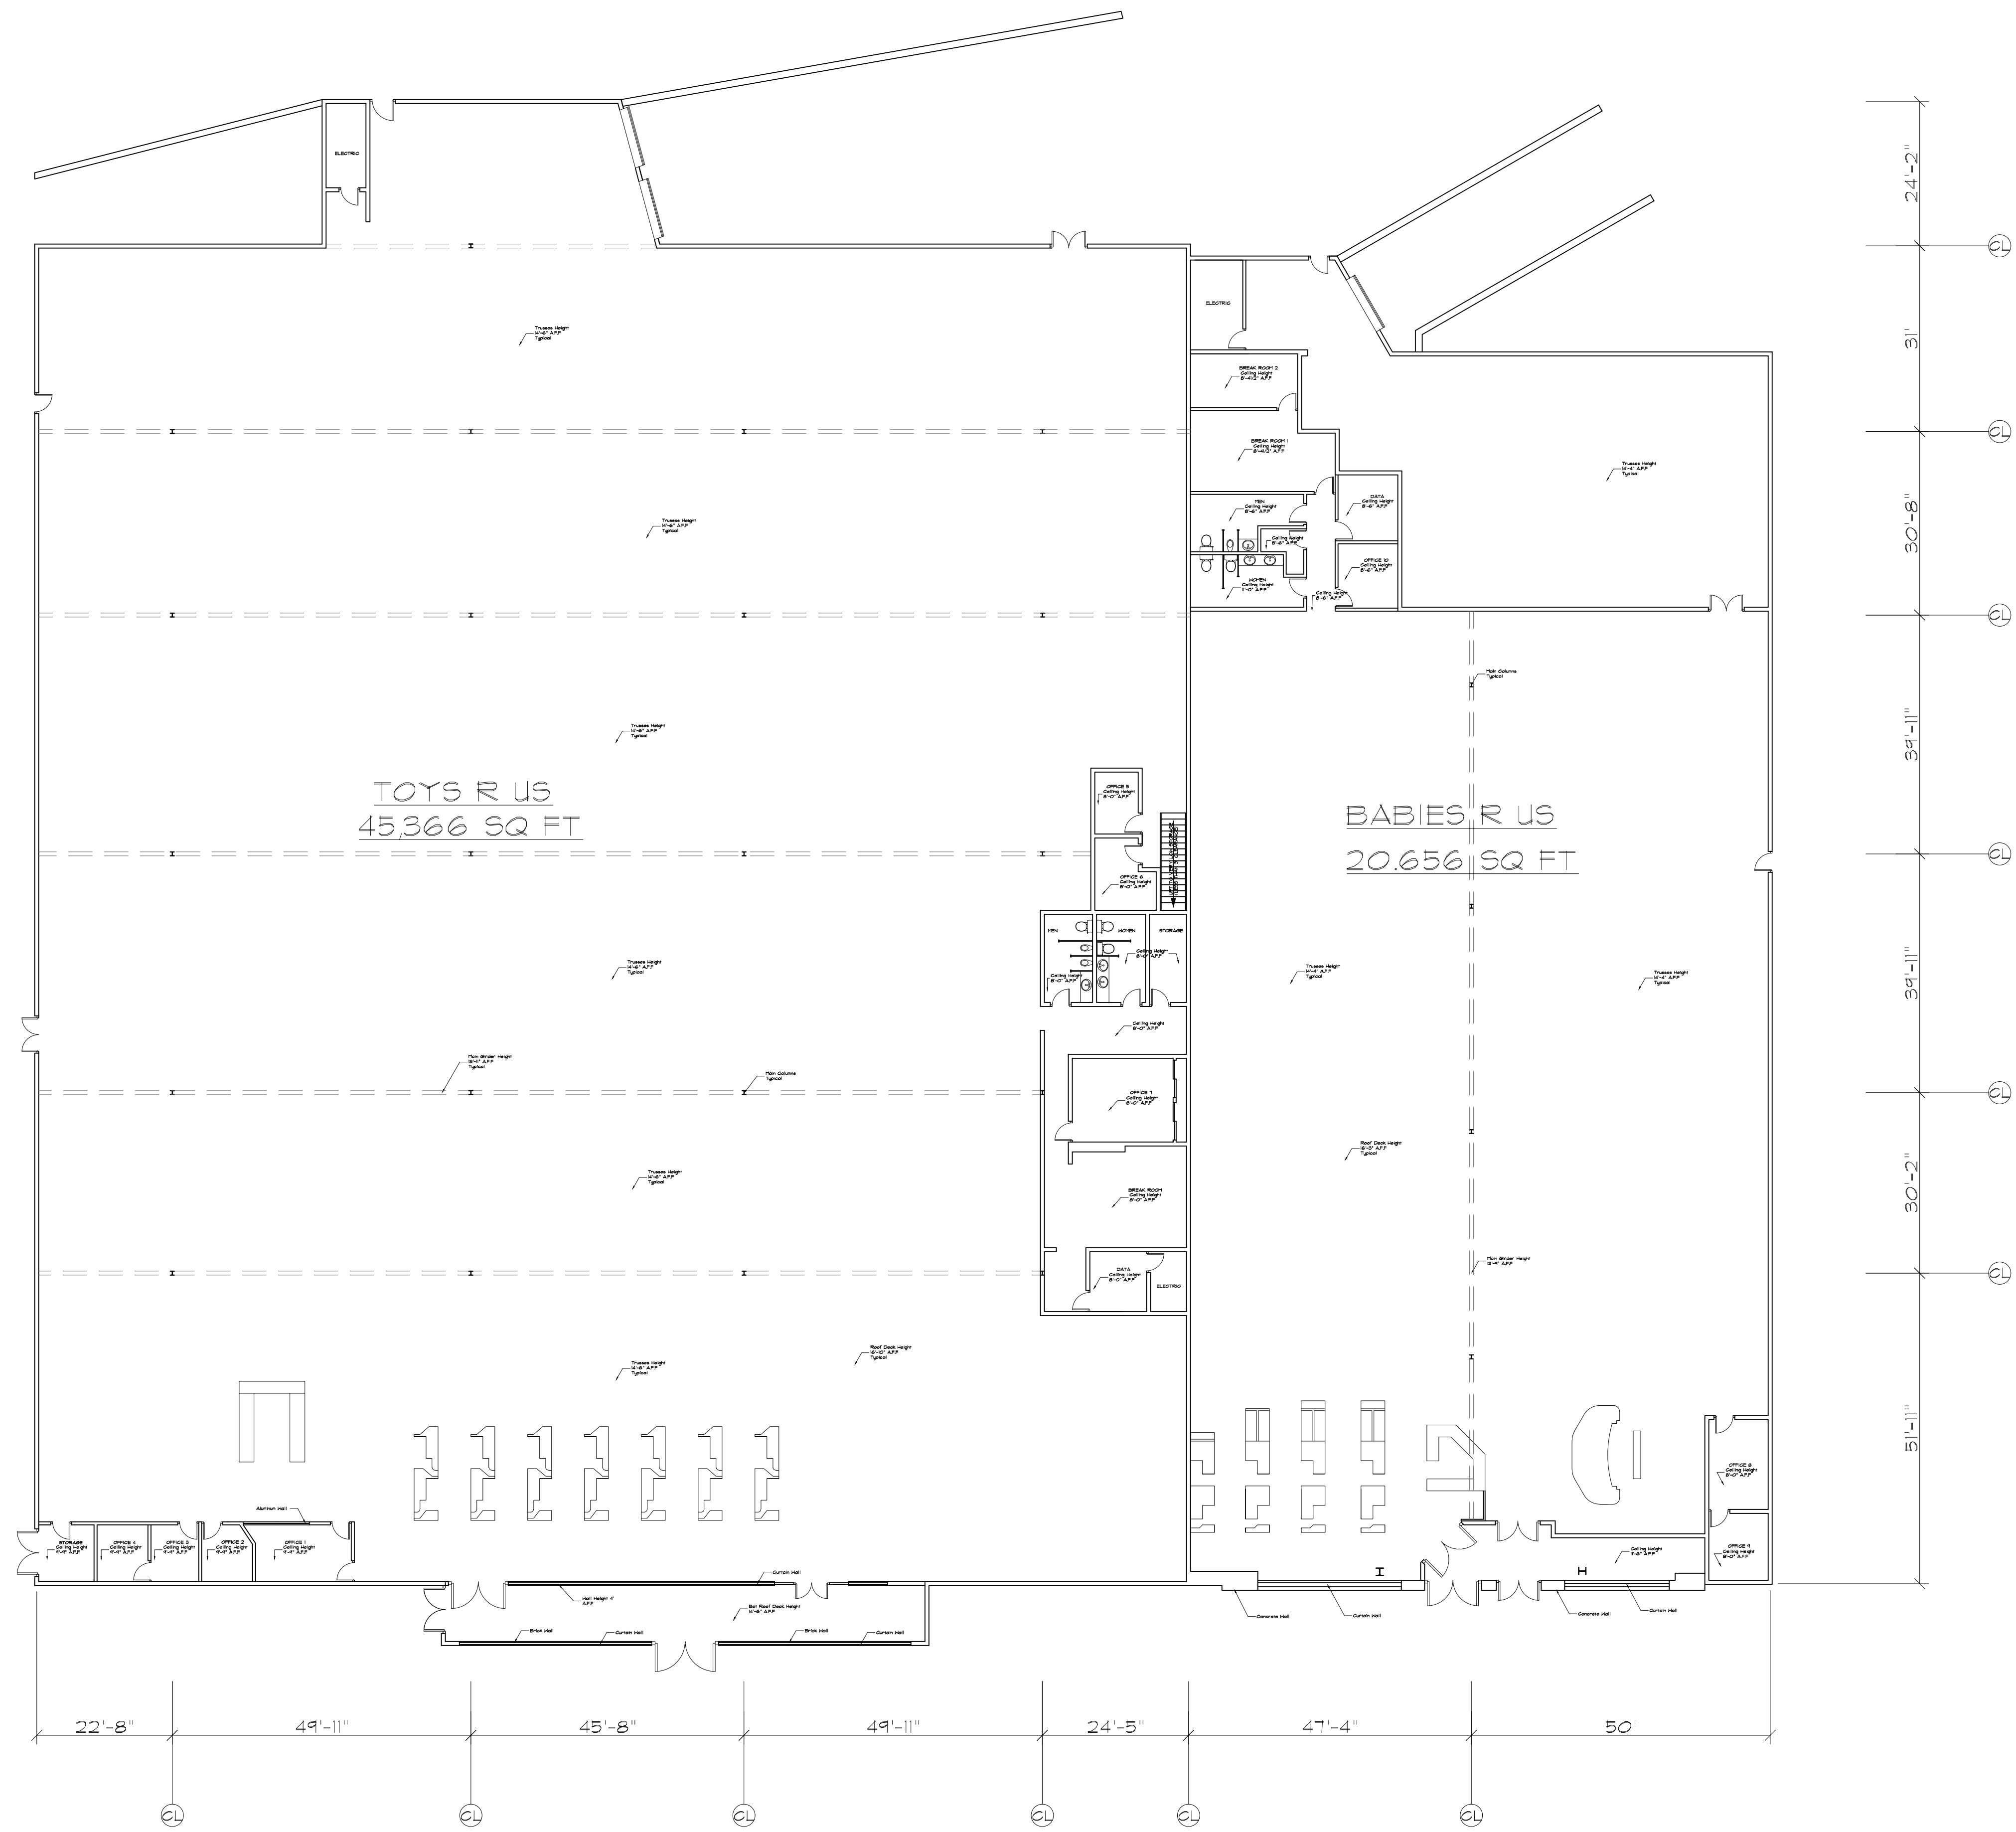

MAIN LEVEL FLOOR PLAN
SCALE 1/16" = 1'-0"

ARCHITECTURAL AS BUILT

Danbury, CT 06810

01 100% SUBMISSION SEE COVER SHEET

NO. ISSUES | REVISIONS DATE

SHEET TITLE

HL PROJECT MANAGER

HL PROJECT DIRECTOR


- PROJECT NUMBER

AS NOTED SCALE


CL DRAWN BY

SHEET NUMBER


AB-1

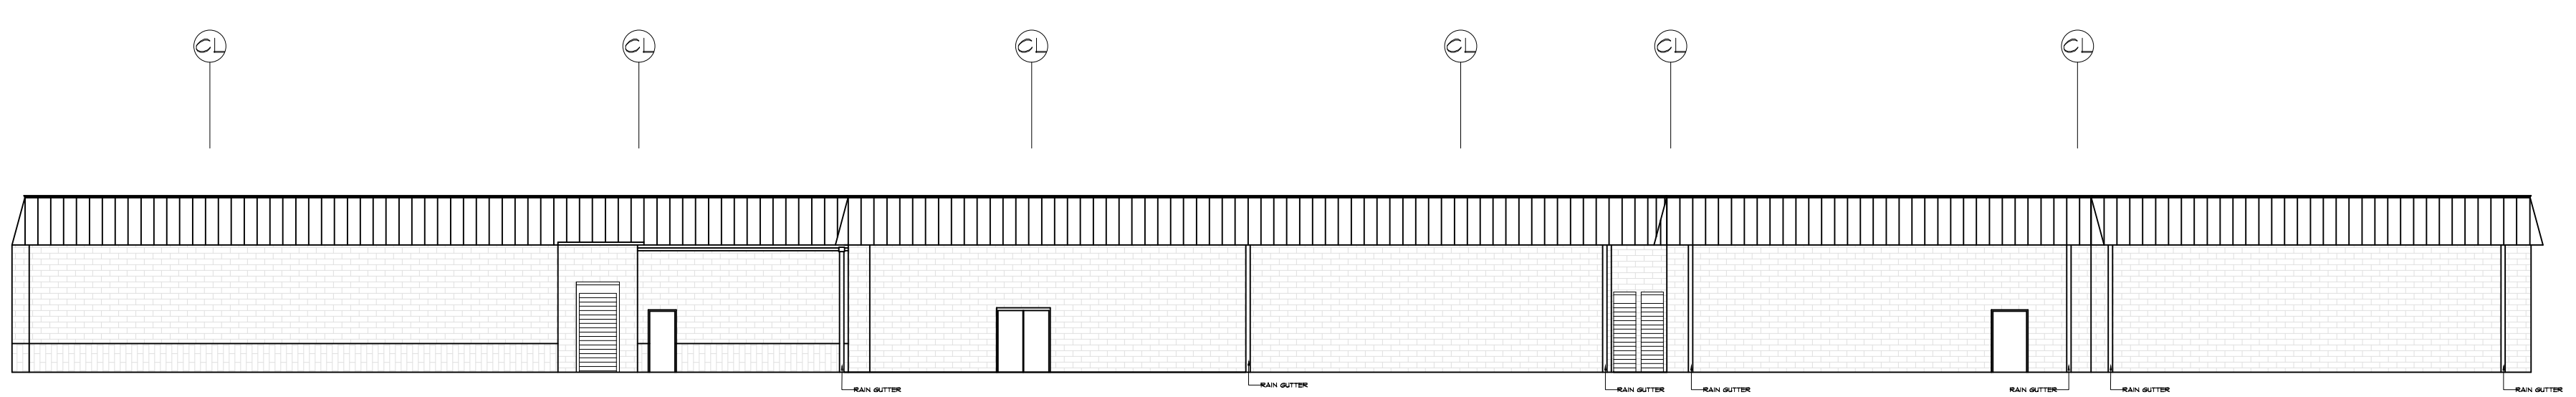


REAR ELEVATION
 SCALE 1/16" = 1'-0"

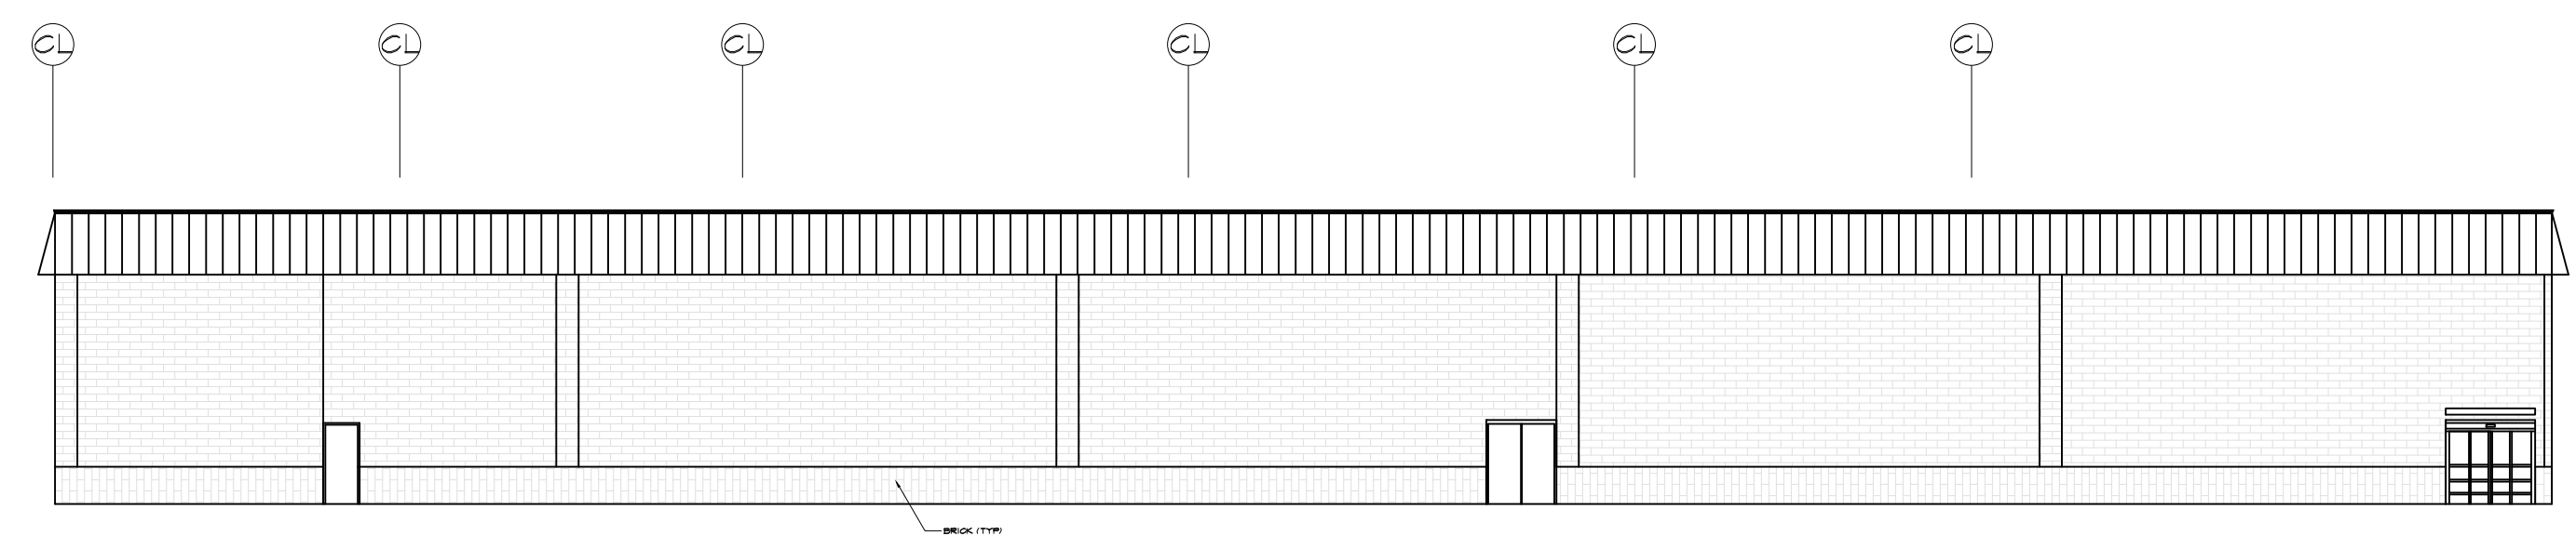

LEFT SIDE
 ELEVATION
 SCALE 1/16" = 1'-0"

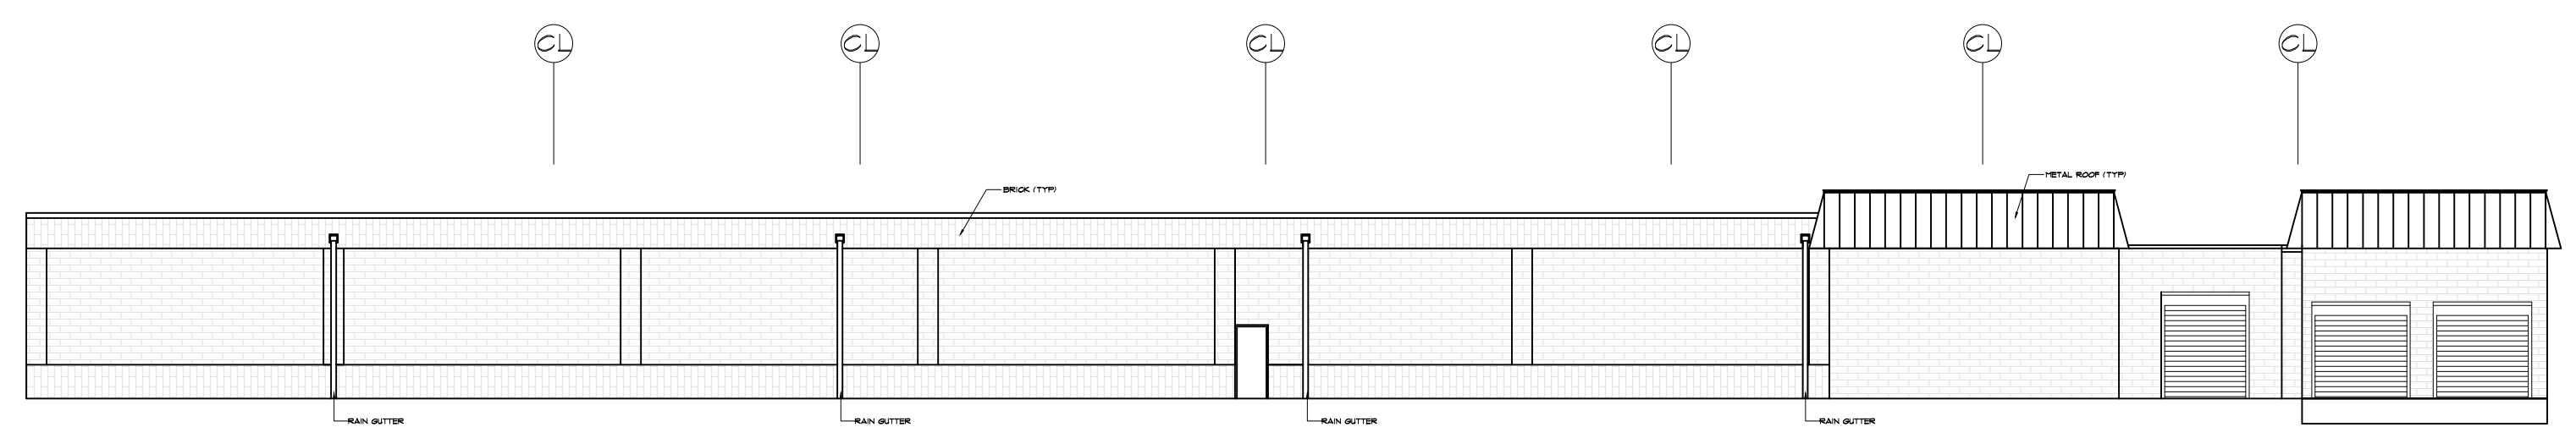

RIGHT SIDE
 ELEVATION
 SCALE 1/16" = 1'-0"

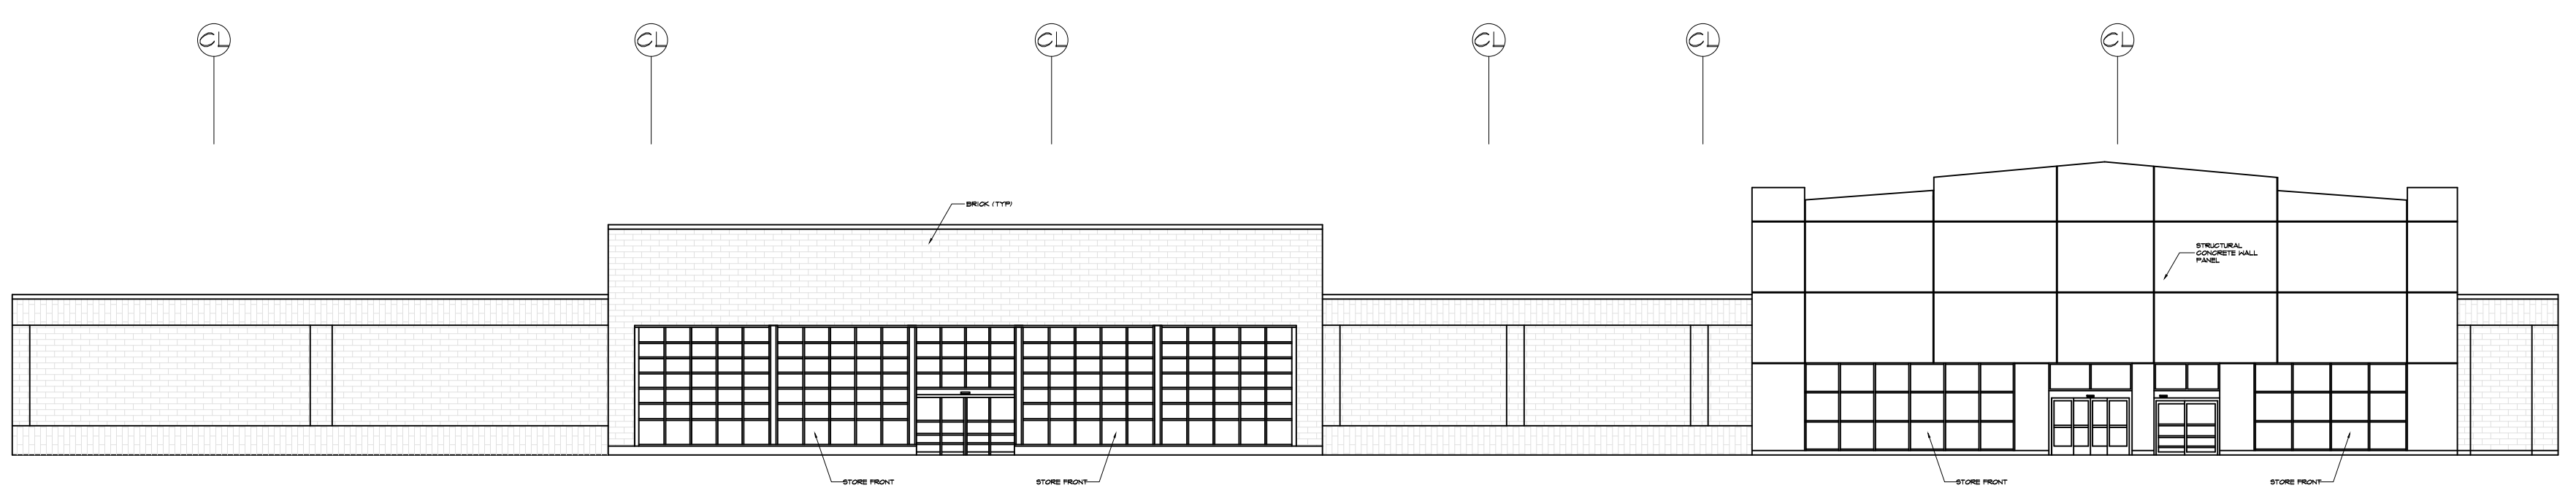

FRONT ELEVATION
 SCALE 1/16" = 1'-0"

ARCHITECTURAL AS BUILT

Danbury, CT 06810

01	100% SUBMISSION	SEE COVER SHEET
NO.	ISSUES REVISIONS	DATE

HL	PROJECT MANAGER
HL	PROJECT DIRECTOR
-	PROJECT NUMBER
AS NOTED	SCALE
CL	DRAWN BY
	SHEET NUMBER