

AS-BUILT DOCUMENTATION

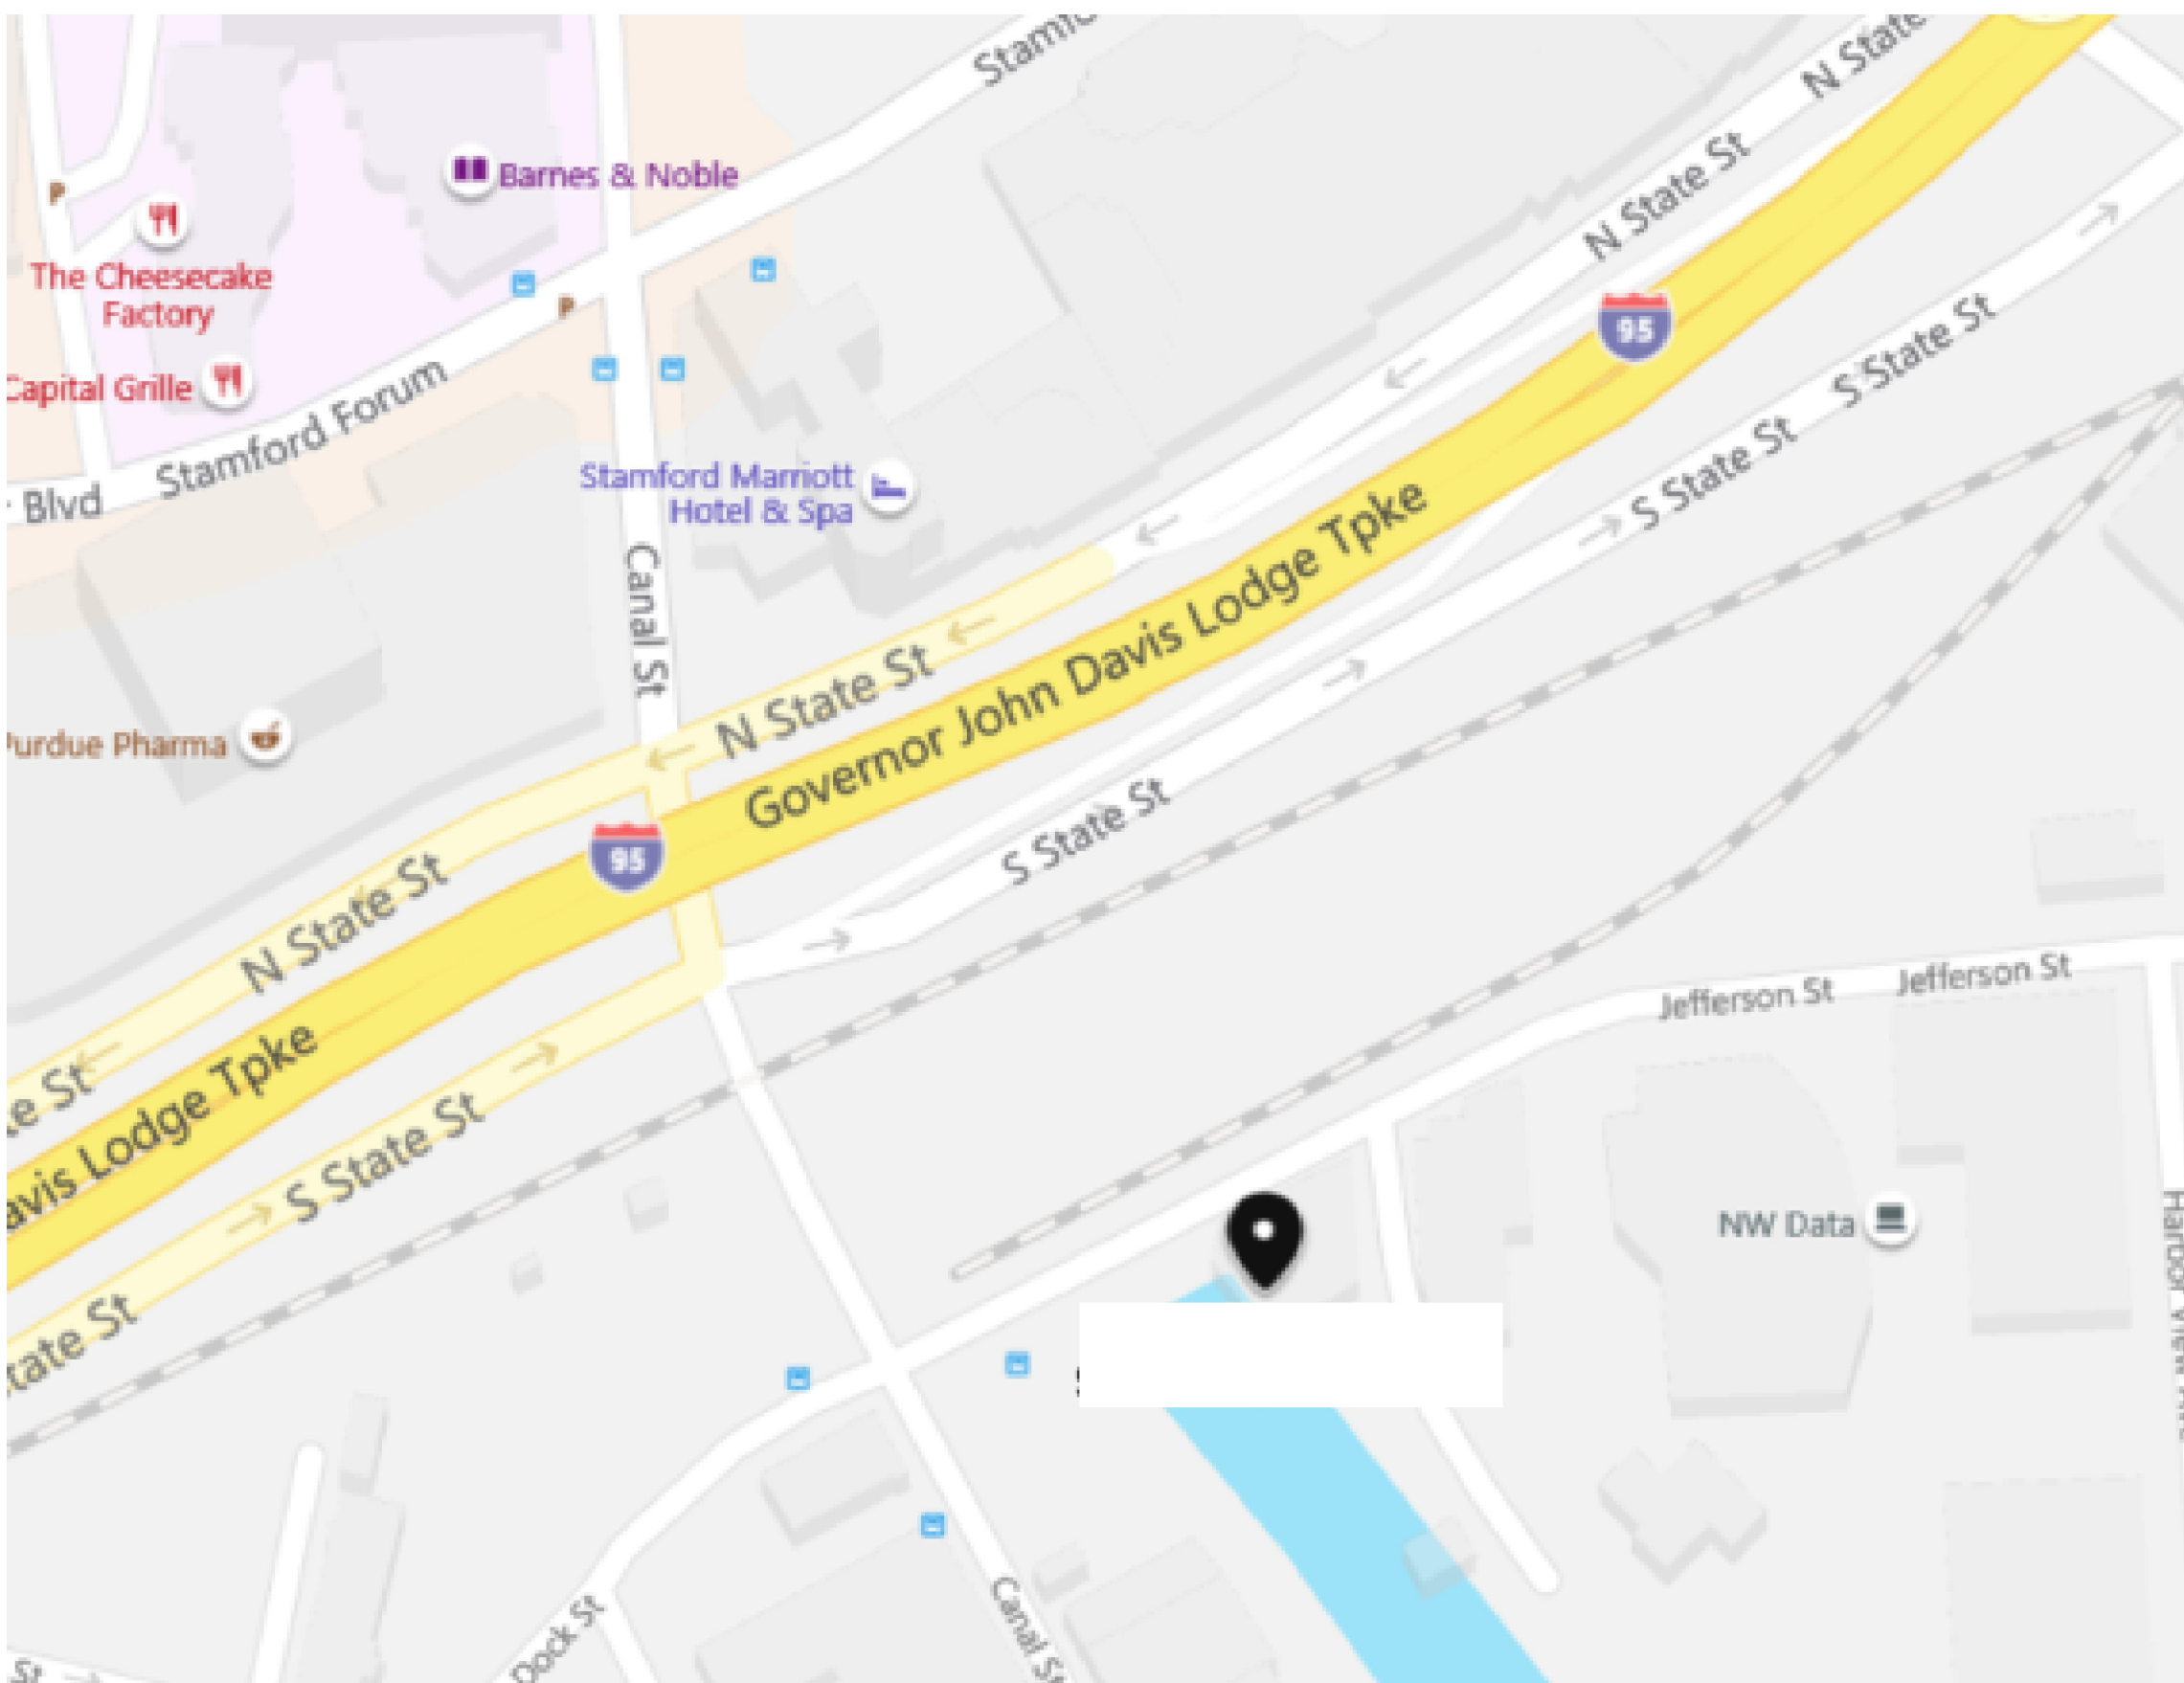
Stamford, CT 06902



100% SUBMITTAL

DRAWING INDEX

- C-1 COVER SHEET | DRAWING INDEX
- SL SYMBOLS LEGEND
- AB-1 BASEMENT PLAN
- AB-2 FIRST FLOOR PLAN
- AB-3 SECOND FLOOR PLAN
- AB-4 THIRD FLOOR PLAN
- AB-5 ROOF PLAN
- AB-6 EXTERIOR ELEVATIONS



VICINITY MAP
NTS

AREA DATA	
BASEMENT	3,823 S.F. ±
FIRST FLOOR	20,186 S.F. ±
SECOND FLOOR	19,353 S.F. ±
THIRD FLOOR	19,353 S.F. ±
BUILDING TOTAL	62,715 S.F. ±

As BUILT

PROFESSIONALS

www.asbuiltprofessionals.com

A DIVISION OF:

AEC

CONSULTANTS INC

844.272.8458

844 AS BUILT

© 2020 AEC CONSULTANTS INC

 
 
 
 
 
 
 
 
 
 
 
ARCHITECTURAL AS BUILT
Stamford, CT 06902

 
 
 
 
 
 
01 100% SUBMISSION	
NO.	ISSUES REVISIONS
DATE	
SHEET TITLE	
COVER SHEET	
HL	PROJECT MANAGER
HL	PROJECT DIRECTOR
012317-1	PROJECT NUMBER
SCALE	
CL	DRAWN BY
SHEET NUMBER	

C-1

SYMBOLS LEGEND

 
 
 
 
 
 
RCP

-  EXHAUST VENT
-  CEILING MOUNTED LIGHT FIXTURE
-  CEILING MOUNTED DIRECTIONAL LIGHT
-  RECESSED CAN LIGHT
-  EYEBALL OR SMALL CAN LIGHT
-  PENDANT LIGHT
-  INDIVIDUAL FLUOR. LAY-IN FIXTURE 4 BULB
-  INDIVIDUAL FLUOR. HANGING FIXTURE 2 BULB
-  INDIVIDUAL FLUOR. FLUSH MOUNT FIXTURE 4 BULB
-  CAMERA
-  MOTION DET.
-  SUPPLY VENT
-  SUPPLY VENT
-  RETURN VENT
-  RETURN VENT
-  SPEAKER

 
 
-  TRACK LIGHT OR VANITY LIGHT
-  WALL-MOUNTED LIGHT FIXTURE
-  EMERGENCY EXIT SIGN
-  EMERGENCY EXIT LIGHT
-  EMERGENCY EXIT LIGHT W/ SIGN
-  LIGHTED STAIR SIGN
-  FLOOD LIGHT
-  PHOTO CELL
-  CEILING FAN
-  CEILING FAN W/ LIGHT KIT
-  JUNCTION BOX

7-2-6 CEILING HEIGHT AND TRIM 7'-2" ABOVE FLOOR BELOW WITH 6" CROWN MOULDING. NOTE: ALL CEILINGS NOT LABELED ARE PLASTER. CEILINGS SHOWN WITH A GRID ARE LAY IN ACOUSTICAL TILE..

ELECTRIC

-  DATA OUTLET
-  TELEPHONE JACK
-  ELECTRIC SWITCH
-  CABLE TELEVISION OUTLET
-  DUPLEX RECEPTACLE OUTLET
-  SPECIAL PURPOSE CONNECTION OR OUTLET
-  QUADRUPLX RECEPTACLE OUTLET
-  FLOOR DUPLEX RECEPTACLE OUTLET
-  ELECTRIC PANEL
-  ELECTRIC METER
-  BUTTON SWITCH
-  DISCONNECT SWITCH
-  GROUND/FLOOR LIGHT
-  KEY PAD

FIRE PROTECTION

-  FIRE EXTINGUISHER
-  FIRE PULL
-  FIRE ALARM (HORN/SRTOBE)
-  SMOKE DETECTOR
-  SMOKE ALARM SPEAKER
-  SPRINKLER HEAD CEILING MOUNT
-  SPRINKLER HEAD WALL MOUNT

MEP

-  THERMOSTAT
-  FLOOR DRAIN
-  VALVE
-  HOSE BIB
-  WATER SUPPLY
-  SUSPENDED GAS HEATER

MISC

-  BOLLARD
-  11-4-11/16 SPOT ELEVATION

7-2-6

CEILING HEIGHT AND TRIM 7'-2" ABOVE FLOOR BELOW WITH 6" CROWN MOULDING. NOTE: ALL CEILINGS NOT LABELED ARE PLASTER. CEILINGS SHOWN WITH A GRID ARE LAY IN ACOUSTICAL TILE..

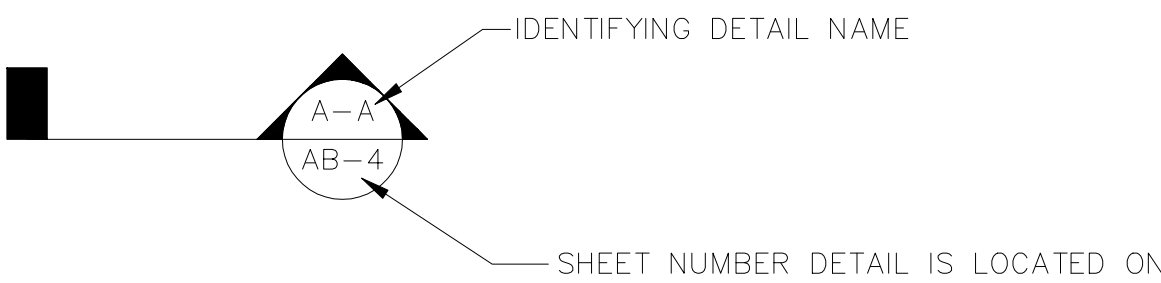
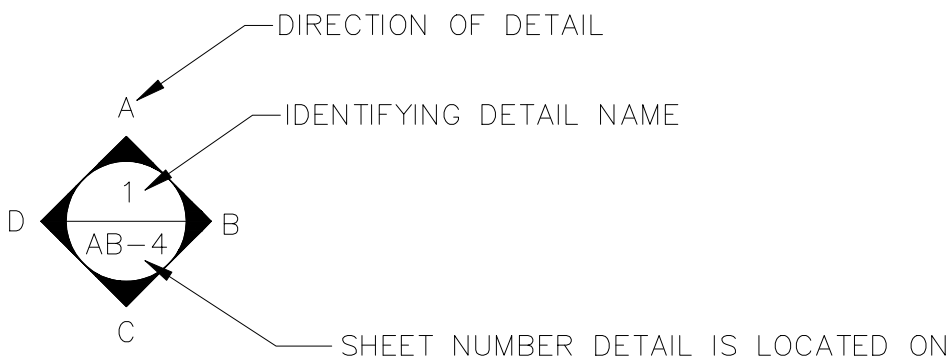


PHOTO DOCUMENTATION LEGEND

-  INDICATES LOCATION OF CAMERA
-  INDICATES DIRECTION OF CAMERA LENS AND CORRESPONDING PHOTO / VIDEO NUMBER

TYPES OF DOCUMENTATION

-  001 GROUND BASED PHOTO
-  V-001 GROUND BASED VIDEO
-  123 360° SPHERICAL PHOTO
-  AERIAL BASED PHOTO
-  AERIAL BASED VIDEO



As BUILT
PROFESSIONALS
www.asbuiltprofessionals.com
A DIVISION OF:



AEC
CONSULTANTS INC
844.272.8458
844 AS BUILT

© 2020 AEC CONSULTANTS INC

ARCHITECTURAL AS BUILT
Stamford, CT 06902

01	100% SUBMISSION		
NO.	ISSUES REVISIONS	DATE	
			SHEET TITLE
HL	PROJECT MANAGER		
HL	PROJECT DIRECTOR		
012317-1			PROJECT NUMBER
NOT TO SCALE			SCALE
CL	DRAWN BY		
			SHEET NUMBER

SL



ARCHITECTURAL AS BUILT

Stamford, CT 06902



BASEMENT PLAN

AB-1



© 2020 AEC CONSULTANTS INC

ARCHITECTURAL AS BUILT

Stamford, CT 06902

01	100% SUBMISSION	
NO.	ISSUES REVISIONS	DATE
		SHEET TITLE
HL		PROJECT MANAGER
HL		PROJECT DIRECTOR
012317-1		PROJECT NUMBER
3/32"=1'-0"		SCALE
CL		DRAWN BY
		SHEET NUMBER

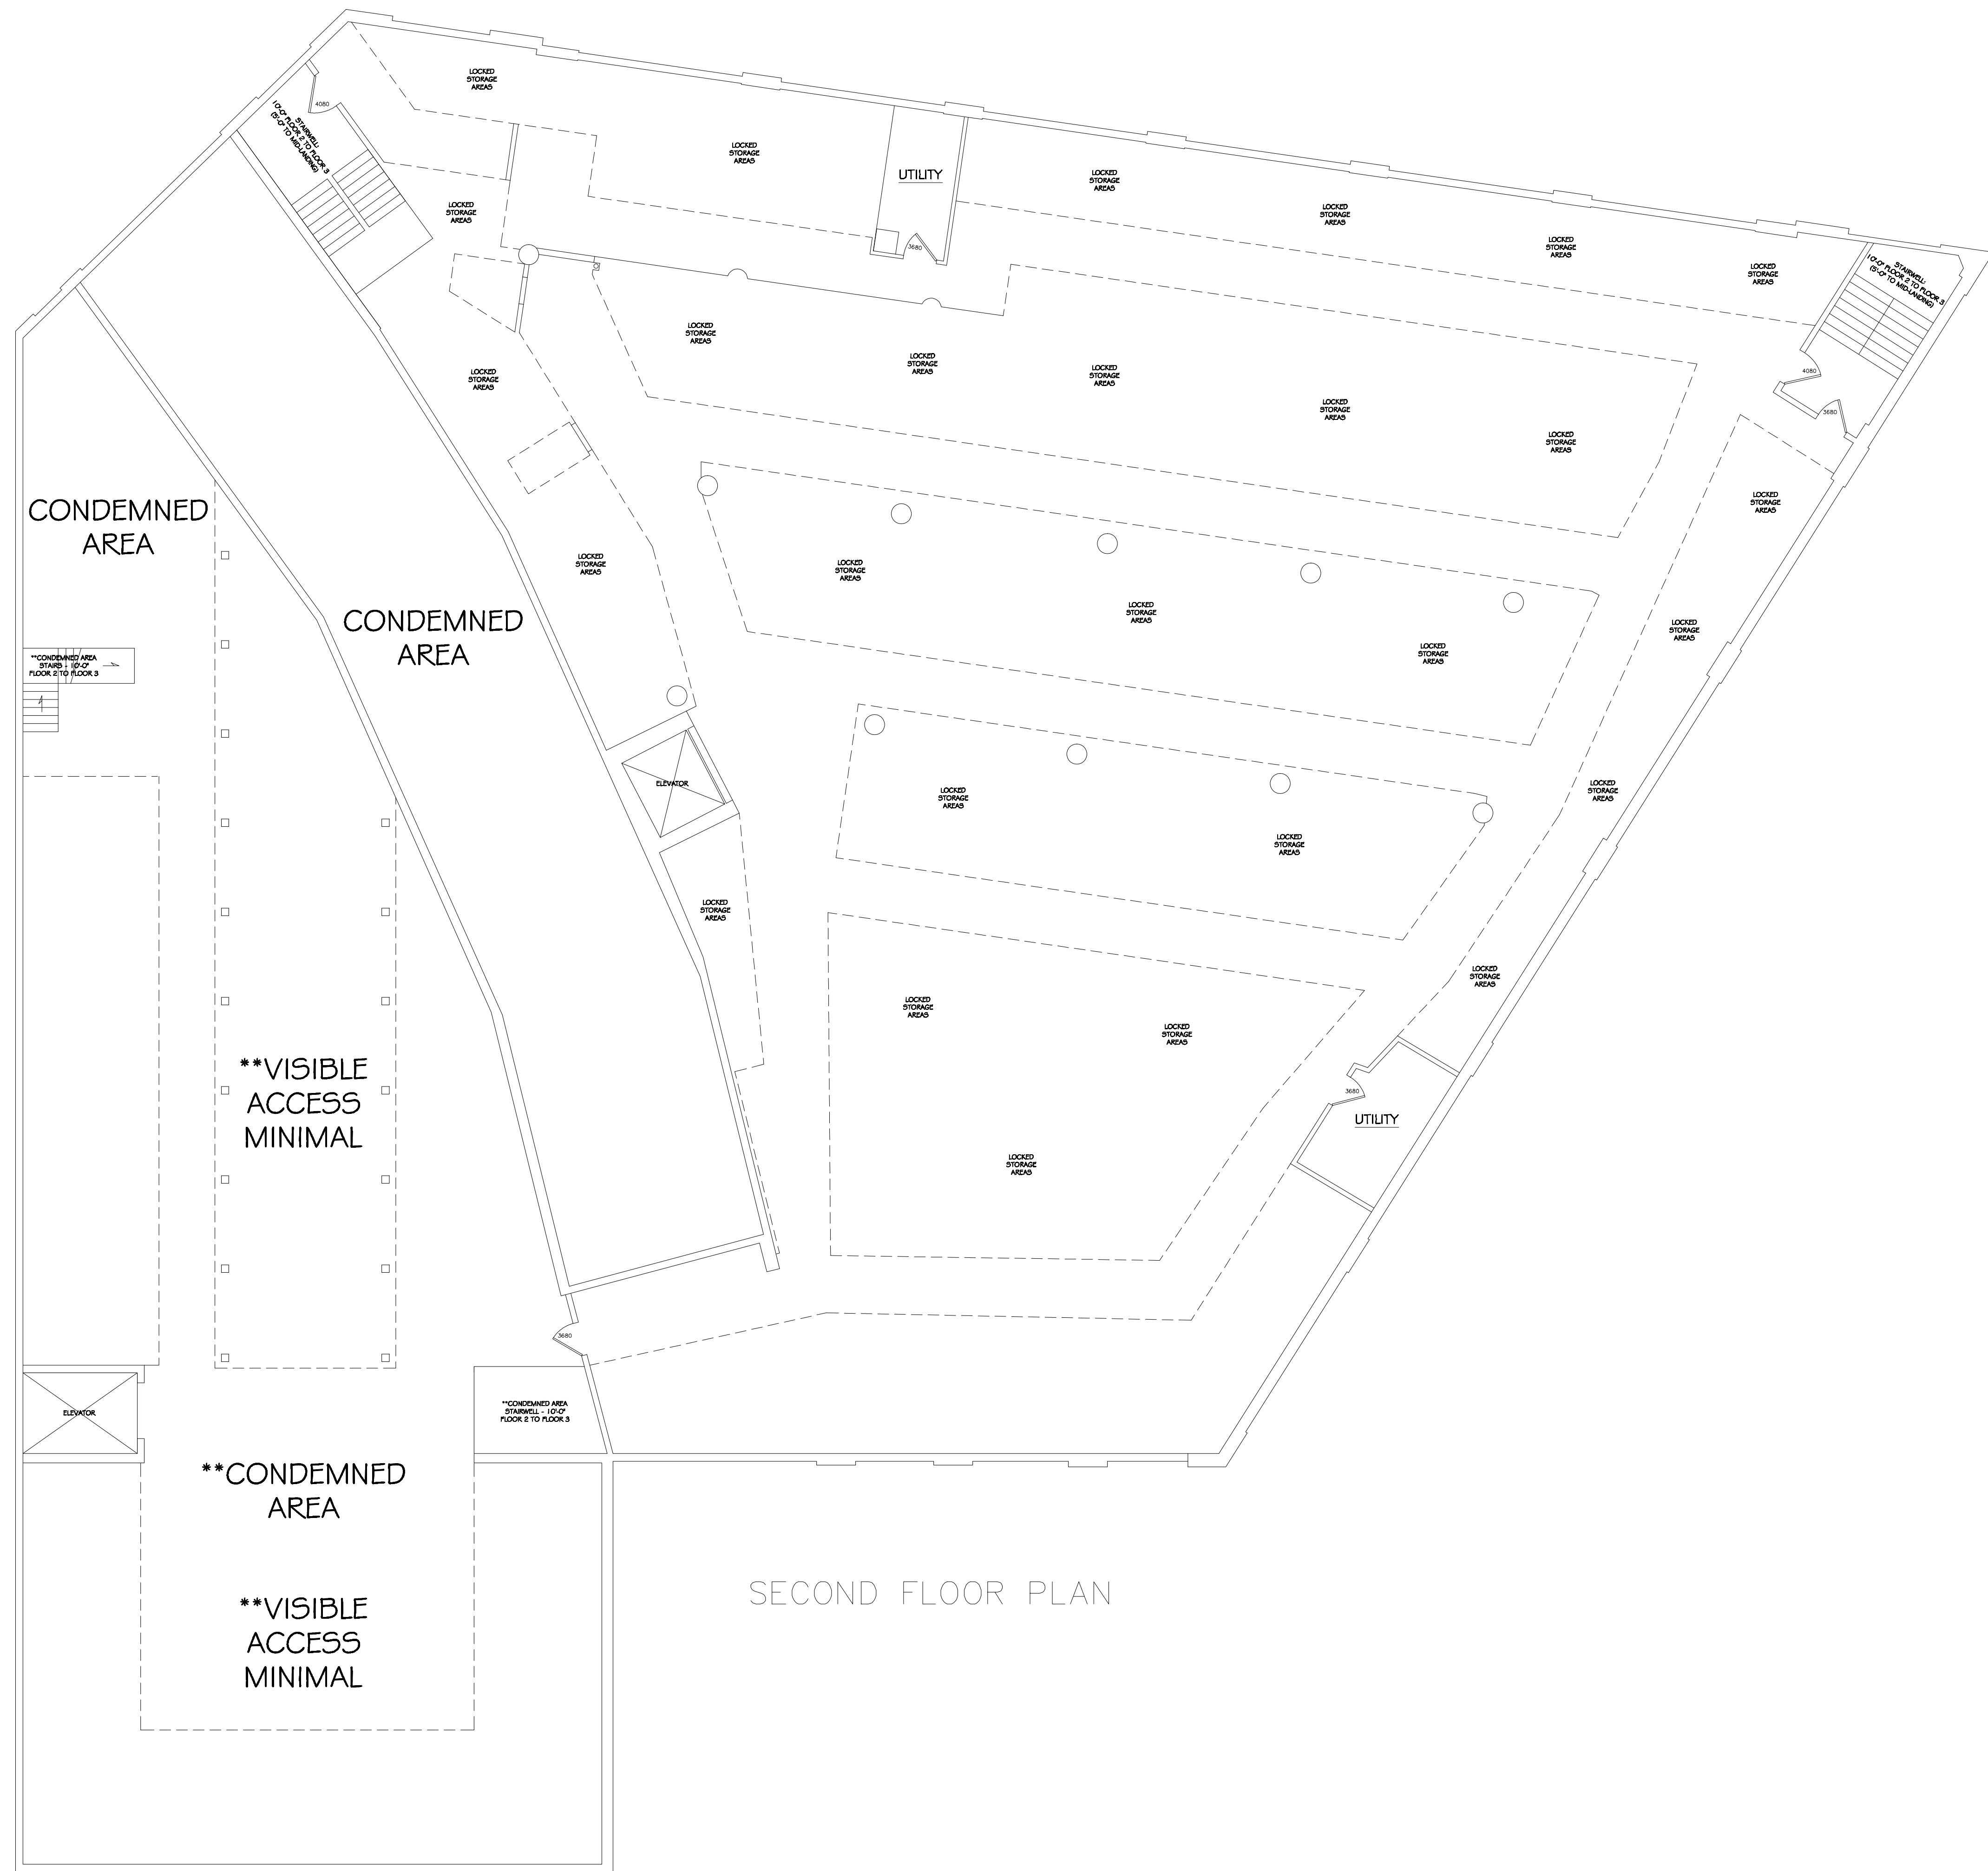
AB-2





ARCHITECTURAL AS BUILT

Stamford, CT 06902



01	100% SUBMISSION	
NO.	ISSUES REVISIONS	DATE
		SHEET TITLE
HL		PROJECT MANAGER
HL		PROJECT DIRECTOR
012317-1		PROJECT NUMBER
1/8"=1'-0"		SCALE
CL		DRAWN BY
		SHEET NUMBER

AB-3

 
[illegible]

AB-4



© 2020 AEC CONSULTANTS INC

Stamford, CT 06902



01	100% SUBMISSION	
NO.	ISSUES REVISIONS	DATE
		SHEET TITLE
HL		PROJECT MANAGER
HL		PROJECT DIRECTOR
012317-1		PROJECT NUMBER
1/4"=1'-0"		SCALE
CL		DRAWN BY
		SHEET NUMBER

AB-5



ARCHITECTURAL AS BUILT

Stamford, CT 06902

01	100% SUBMISSION	
NO.	ISSUES REVISIONS	DATE
		SHEET TITLE
HL		PROJECT MANAGER
HL		PROJECT DIRECTOR
012317-1		PROJECT NUMBER
3/32"=1'-0"		SCALE
CL		DRAWN BY
		SHEET NUMBER

AB-6

