


POOL LEVEL FLOOR PLAN
LOWER LEVEL FLOOR PLAN
SCALE: 1/4" = 1'-0"

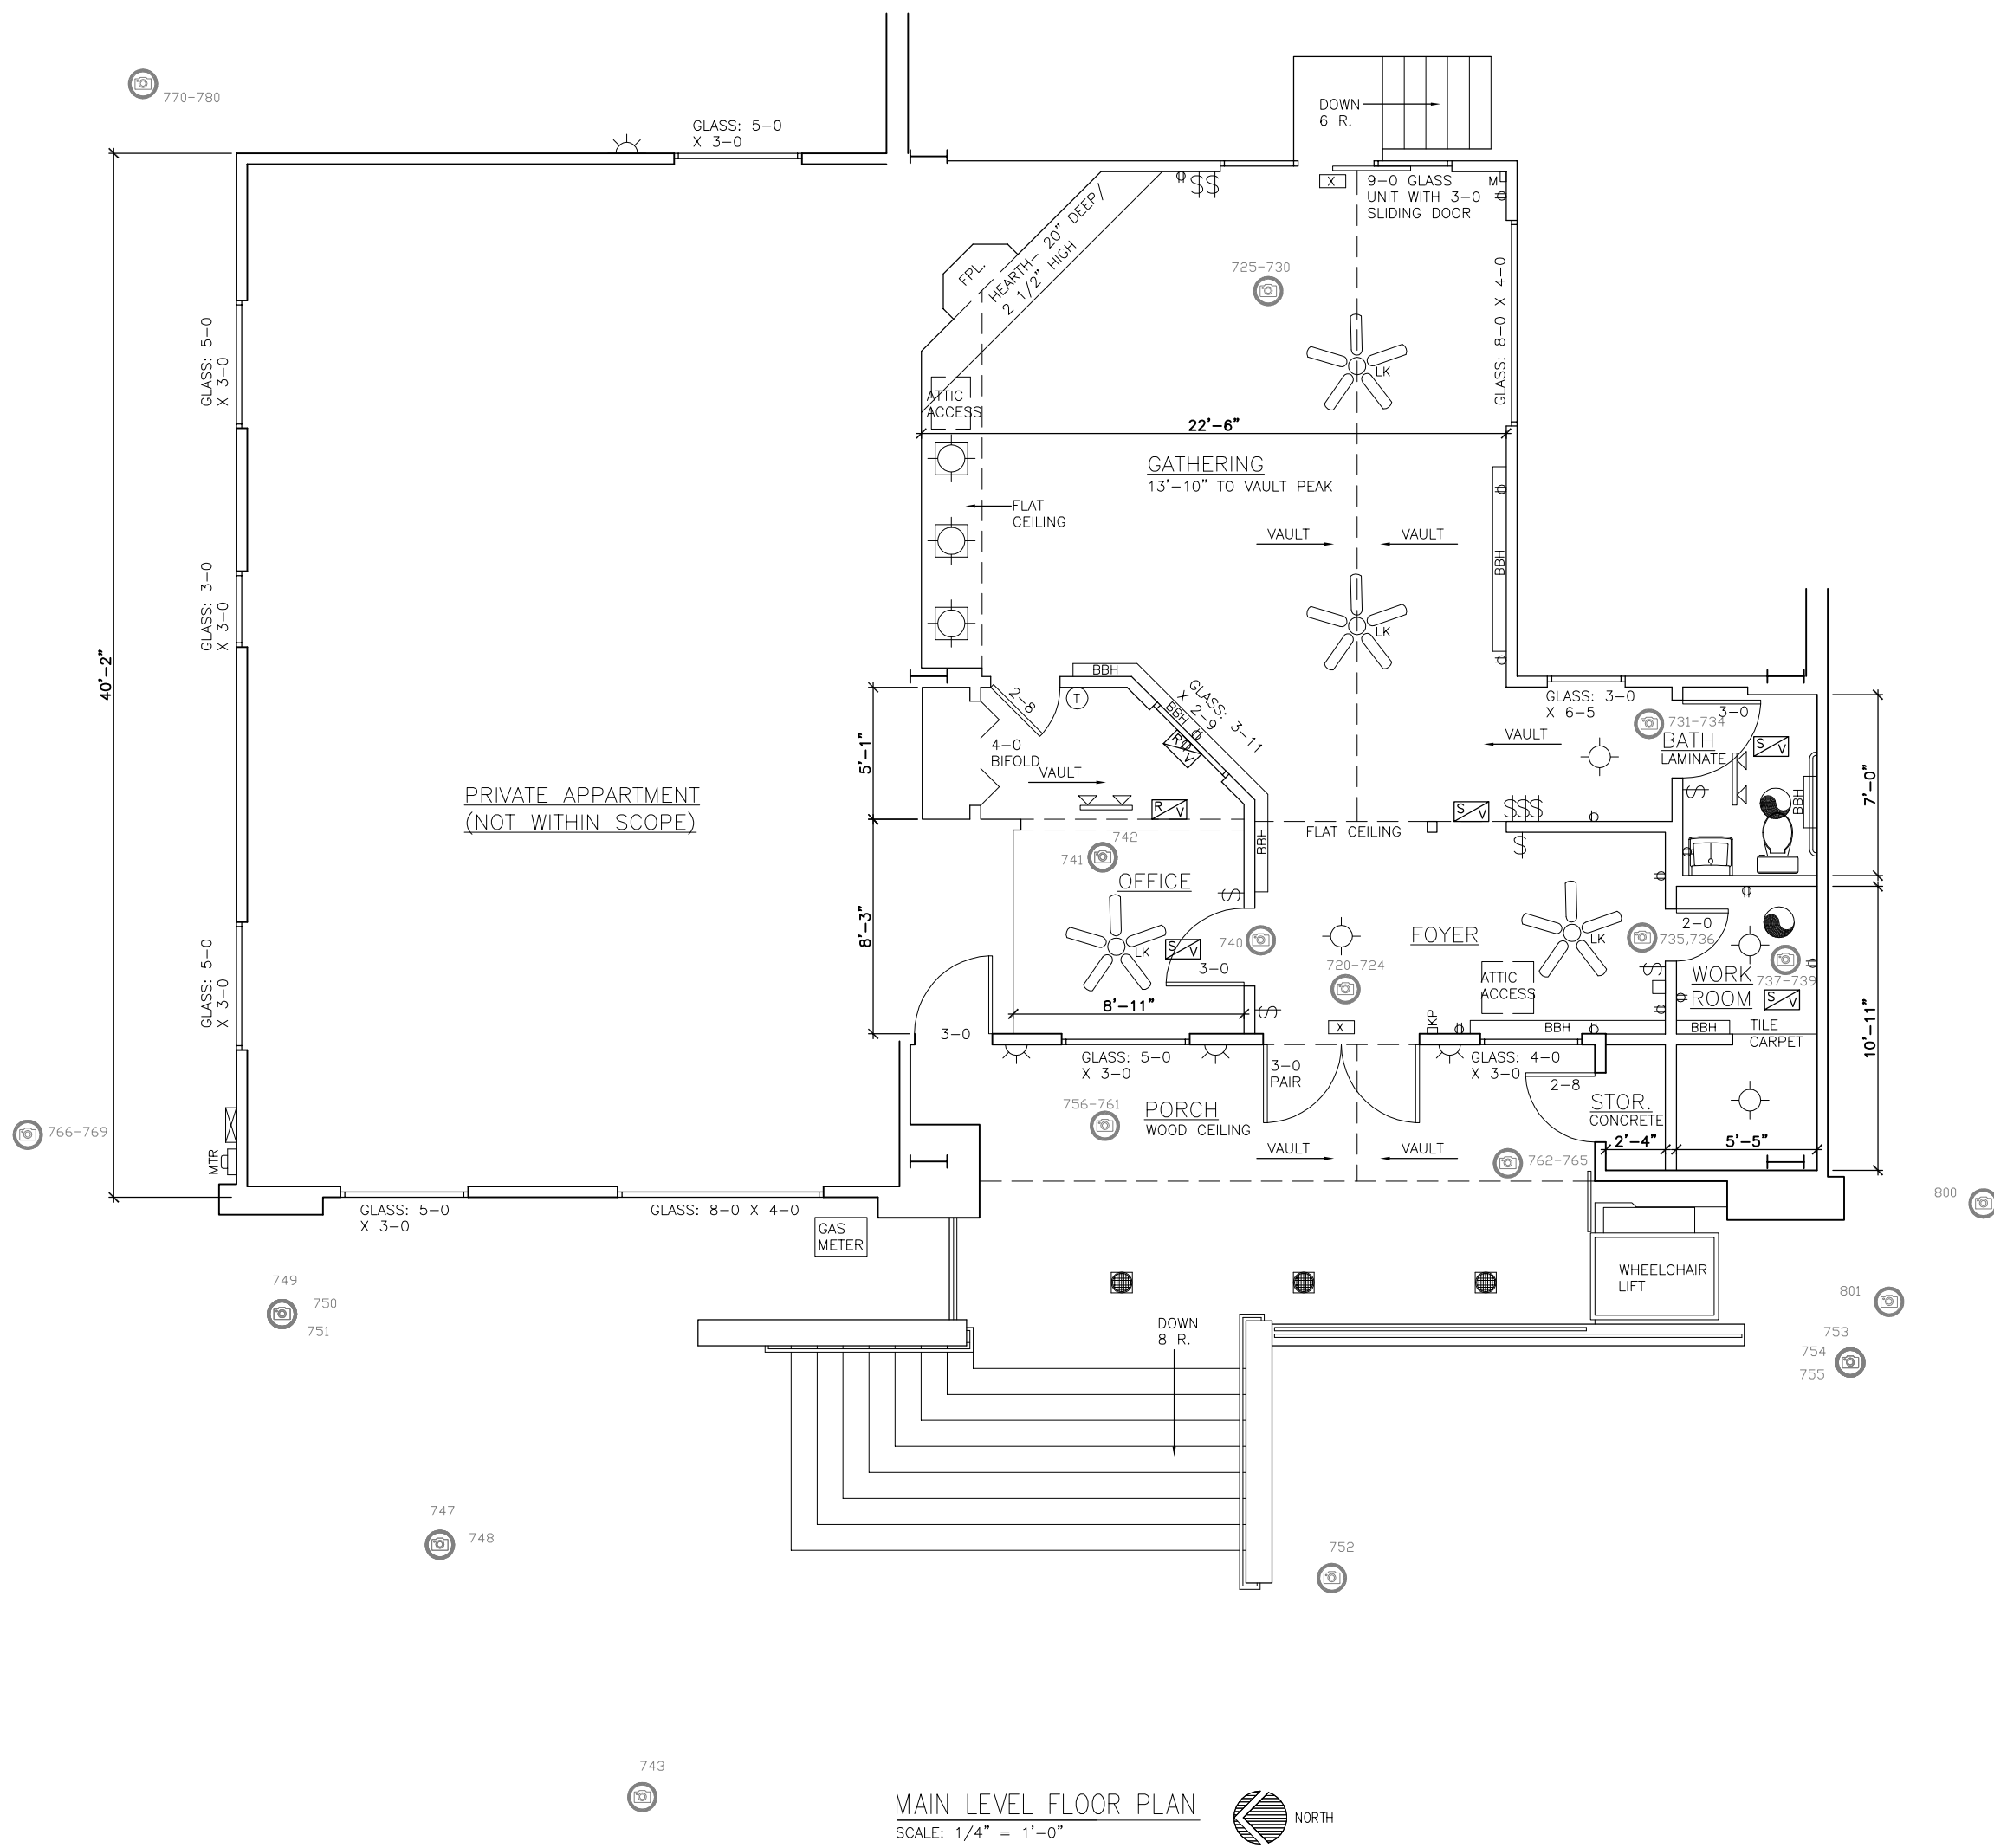

MAIN LEVEL FLOOR PLAN
SCALE: 1/4" = 1'-0"

LEGEND			
EXHAUST VENT	TEL	TELEPHONE JACK	
CEILING MOUNTED LIGHT FIXTURE	S1	ELECTRIC SWITCH	
RECESSED CAN LIGHT	S3	3-WAY ELECTRIC SWITCH	
WALL-MOUNTED LIGHT FIXTURE	P1	DUPLEX RECEPTACLE OUTLET	
EMERGENCY EXIT SIGN	0220	220V RECEPTACLE OUTLET	
VANITY BAR LIGHT FIXTURE	0610	CEILING OUTLET	
INDIVIDUAL FLOOR, FUTURE 4 BULB	WP	WATERPROOF DUPLEX RECEPTACLE OUTLET	
INDIVIDUAL FLOOR, FUTURE 2 BULB	SD	SMOKE DETECTOR	
BASEBOARD HEATER	PNL	ELECTRIC PANEL	
CEILING FAN	MTR	ELECTRIC METER	
CEILING FAN W/ LIGHT KIT	TH	THERMOSTAT	
DISCONNECT SWITCH	COO	COMP. DATA OUTLET	
FLOOR DRAIN	TL	TRACK FIXTURE	
MOTION SENSOR	DKP	ALARM KEY PAD	
HYVAC SUPPLY VENT			
HYVAC RETURN VENT			

NOTES:
1. ALL CEILINGS ARE 7'-10" ± 8' A.F.F.E. AND ARE A TEXTURED FINISH OVER GYP BD UNO.
2. ALL FLOORING IS CARPET UNO.
3. FURNITURE AND PERSONAL ARTICLES WERE NOT MOVED ONLY VISIBLE UTILITIES LOCATED.




PHOTO DOCUMENTATION LEGEND	
INDICATES LOCATION OF CAMERA	
INDICATES DIRECTION OF CAMERA LENS AND CORRESPONDING PHOTO NUMBER (LAST THREE DIGITS ONLY)	
INDICATES A RANGE OF PHOTOS TAKEN FROM SAME POINT AND CORRESPONDING PHOTO NUMBERS (LAST THREE DIGITS ONLY)	

FACILITY DOCUMENTATION: VILLAGE GARDEN APARTMENTS

Fort Collins, CO 80525

NO.	ISSUES REVISIONS	DATE
SHEET TITLE		
HL	PROJECT MANAGER	
HL	PROJECT DIRECTOR	
XX,XX,XX	PROJECT NUMBER	
AS NOTED	SCALE	
G.R.	DRAWN BY	
SHEET NUMBER		

A-1





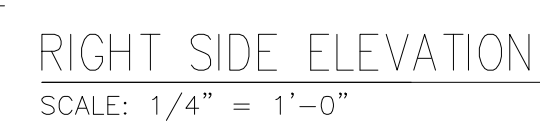
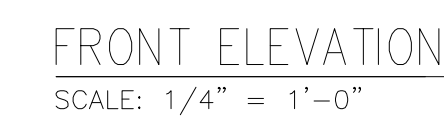
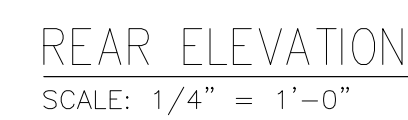


FACILITY DOCUMENTATION: VILLAGE GARDEN APARTMENTS

Fort Collins, CO 80525

NO.	ISSUES REVISIONS	DATE
		SHEET TITLE

HL	PROJECT MANAGER
HL	PROJECT DIRECTOR
XX.XX.XX	PROJECT NUMBER
AS NOTED	SCALE
G.R.	DRAWN BY
	SHIFT NUMBER

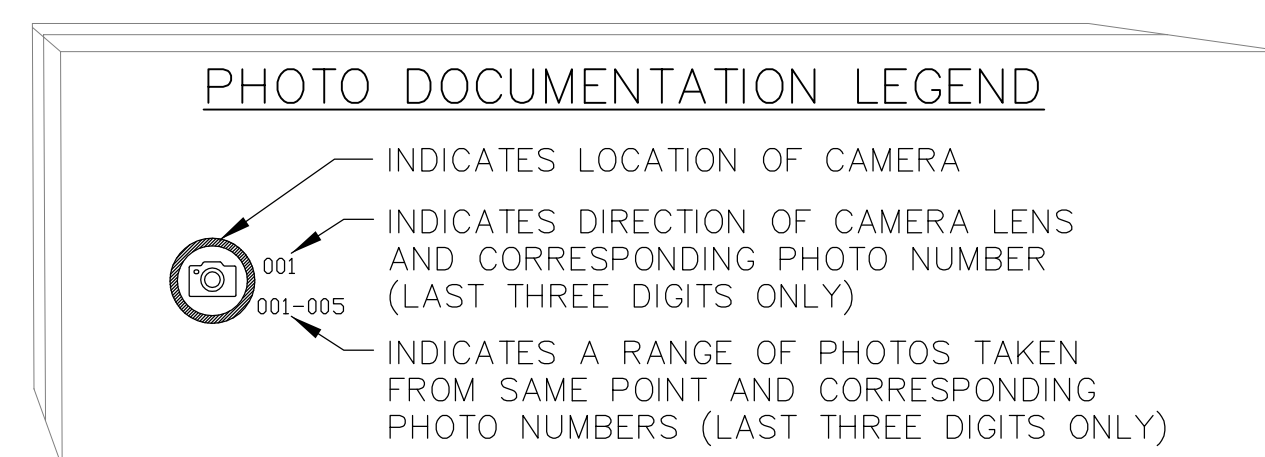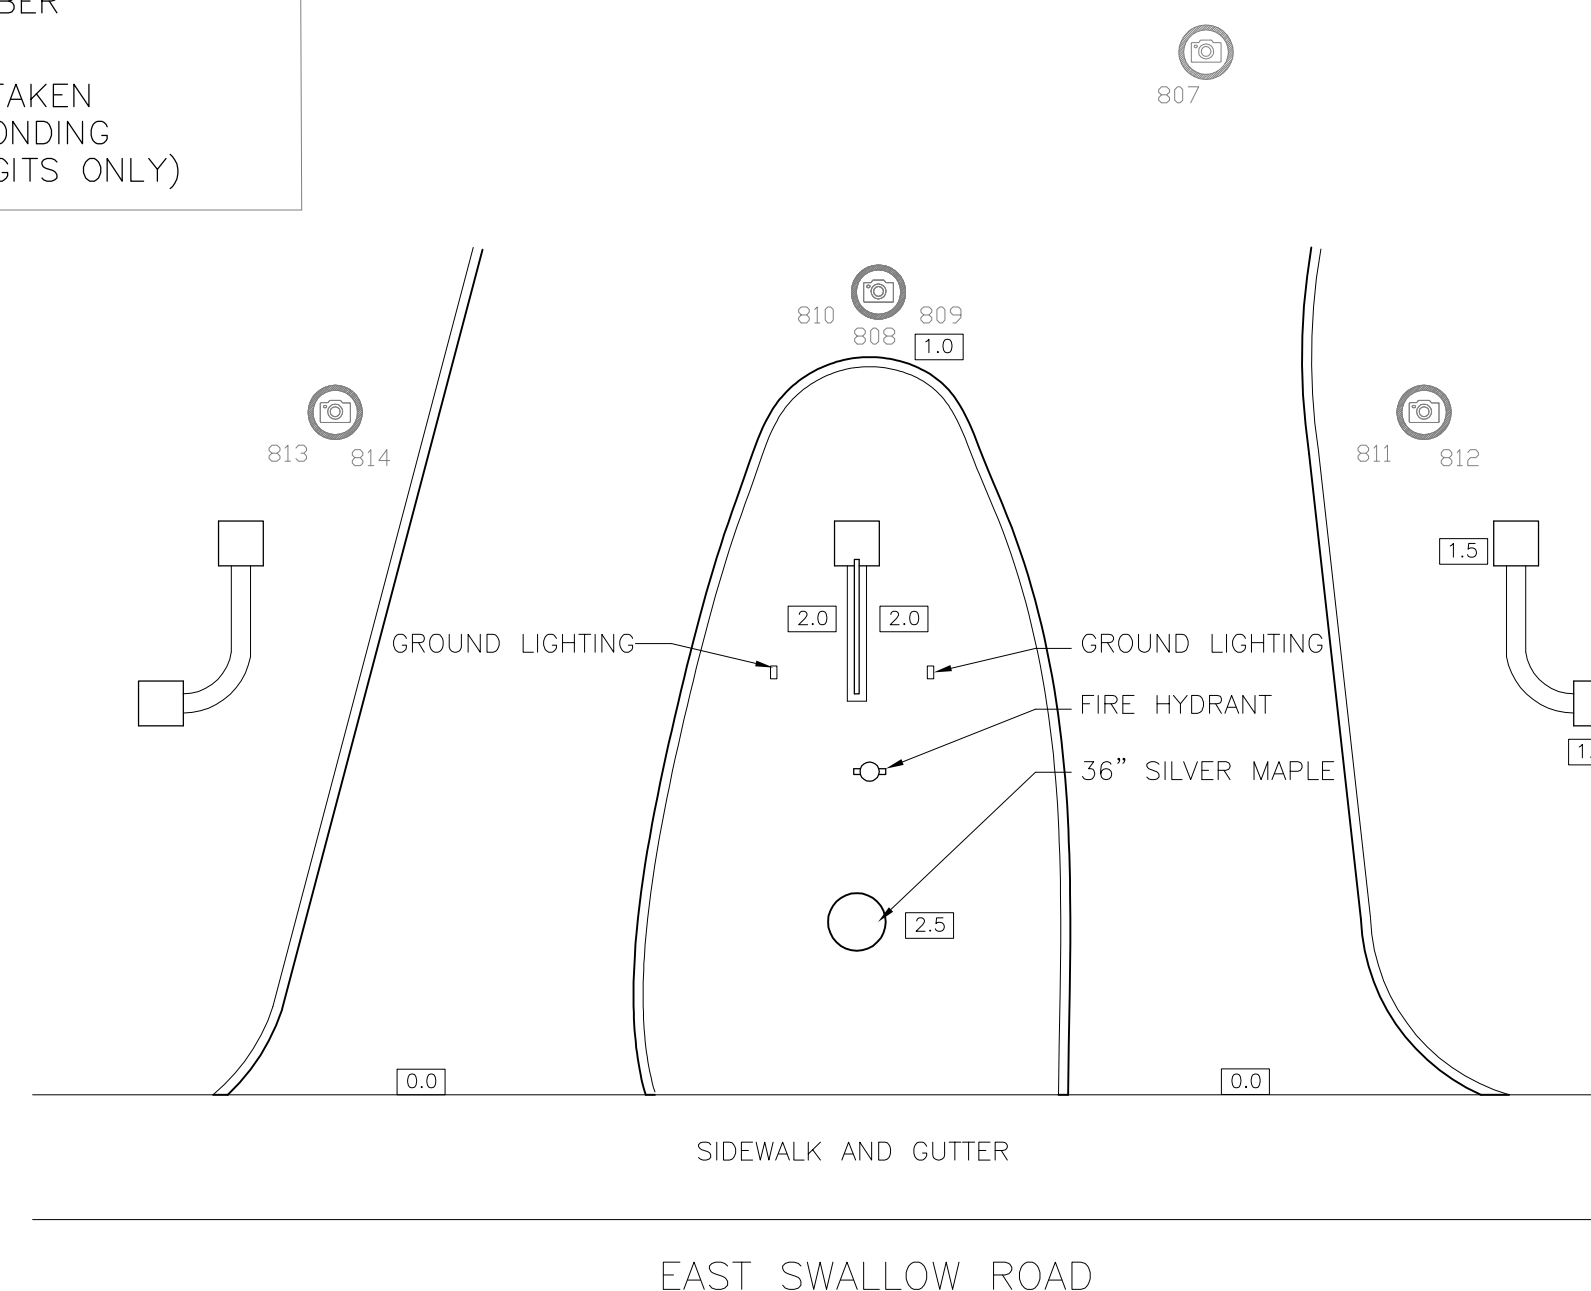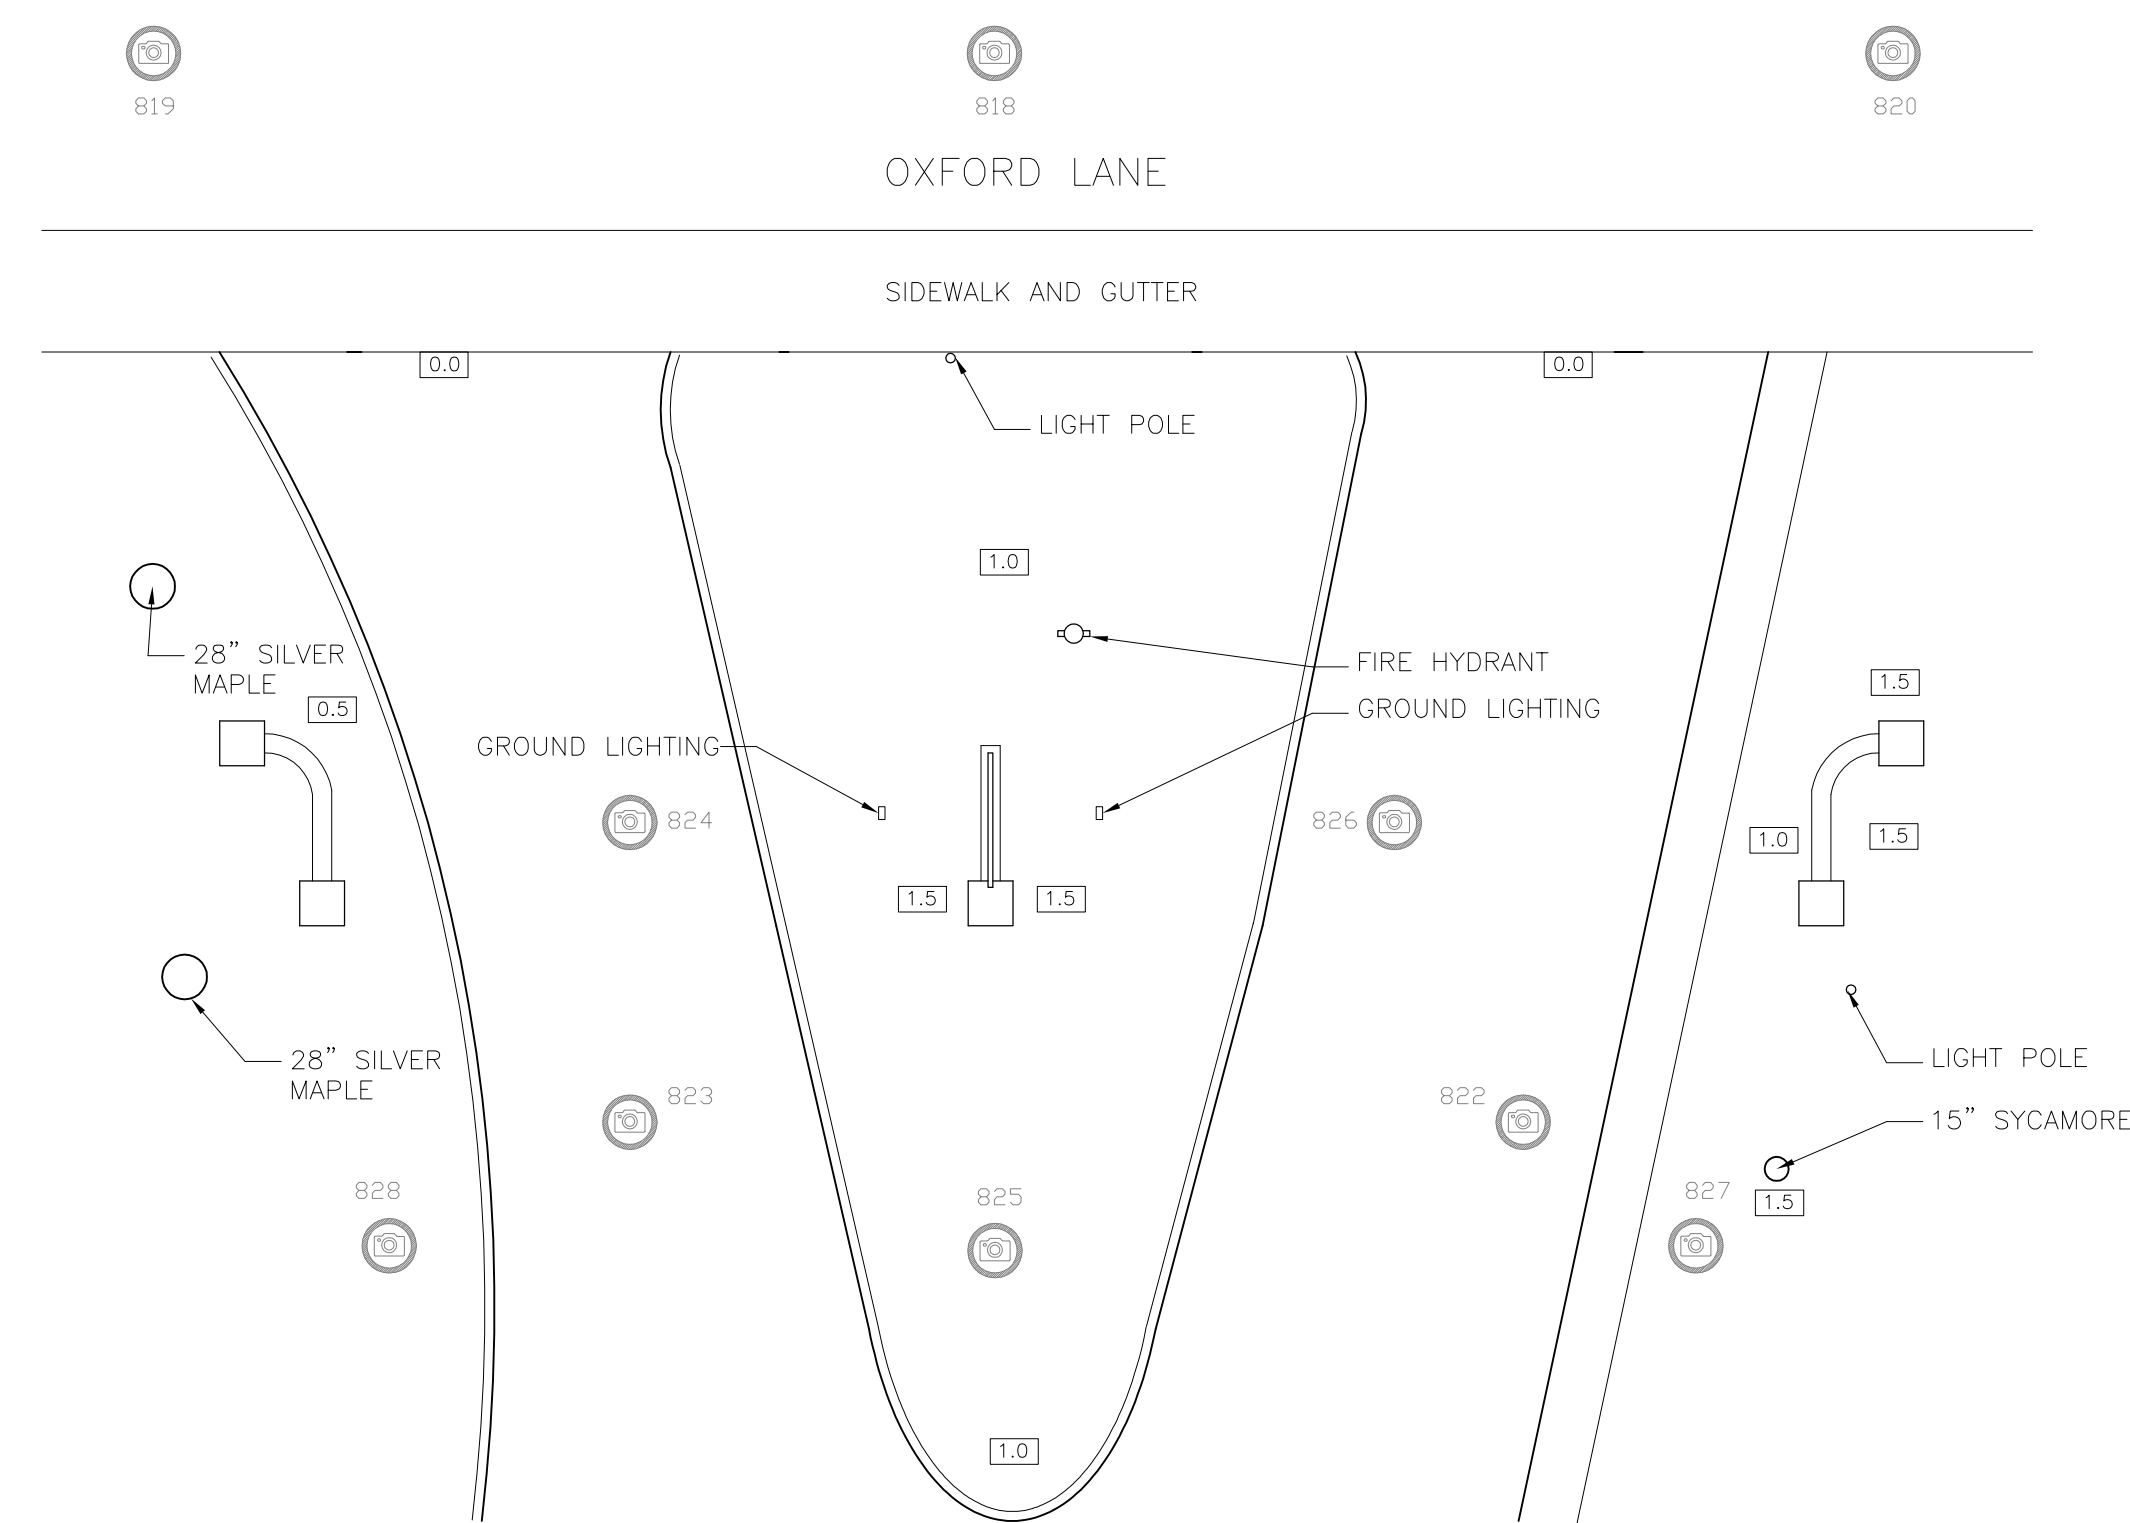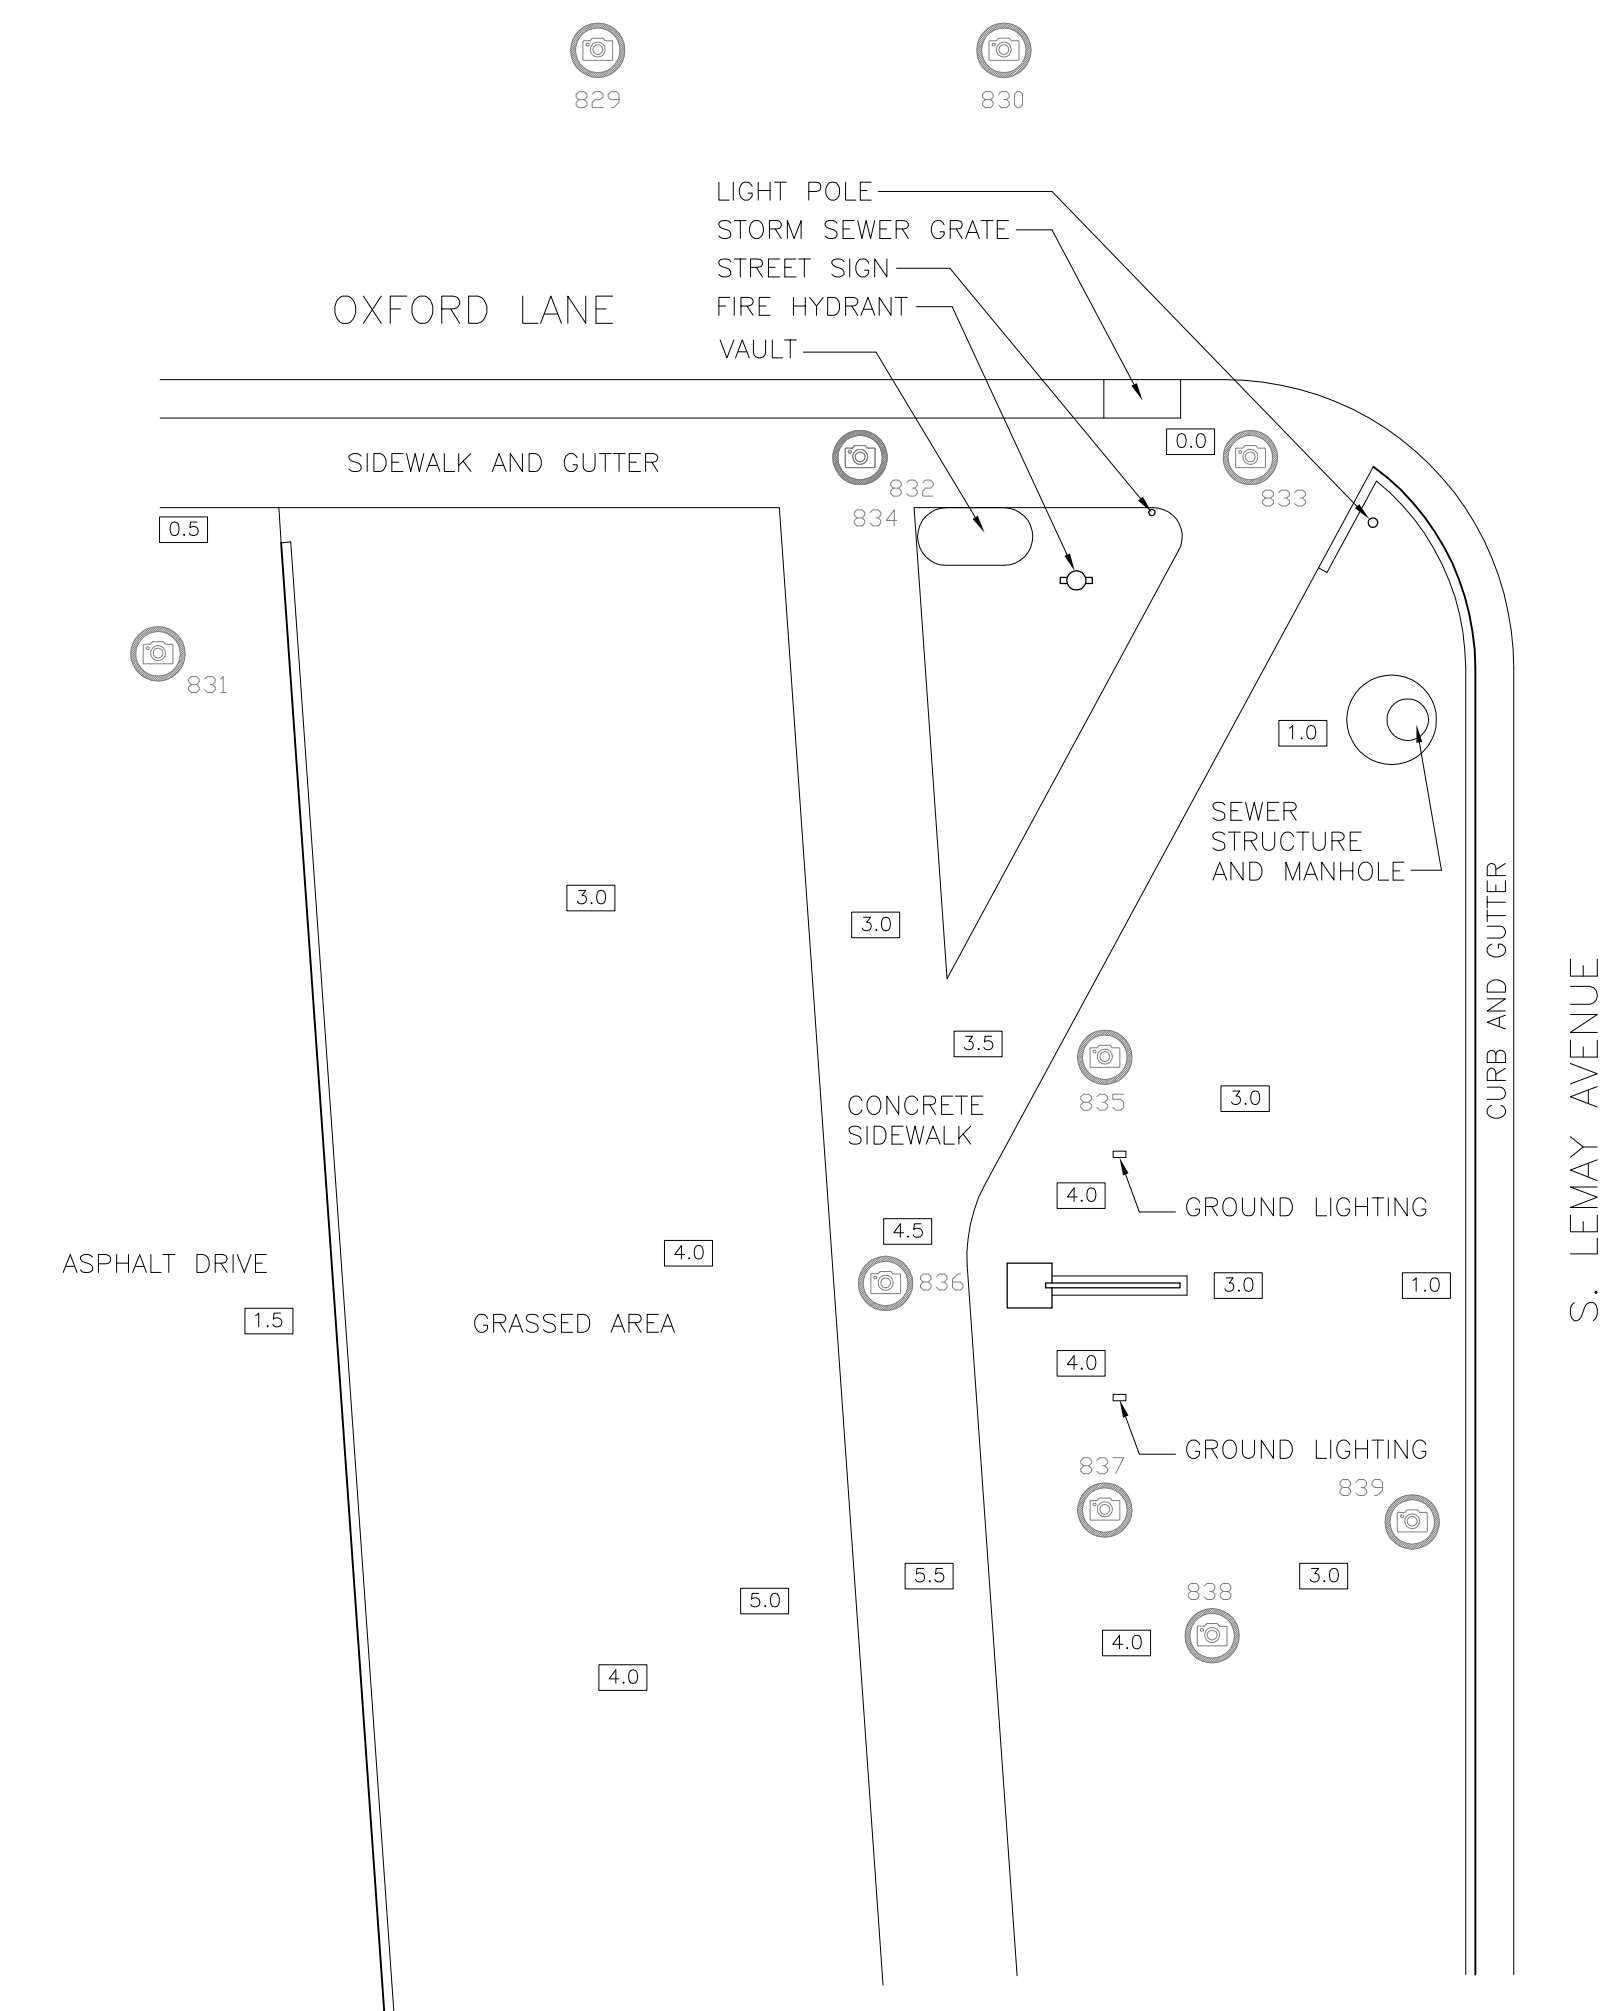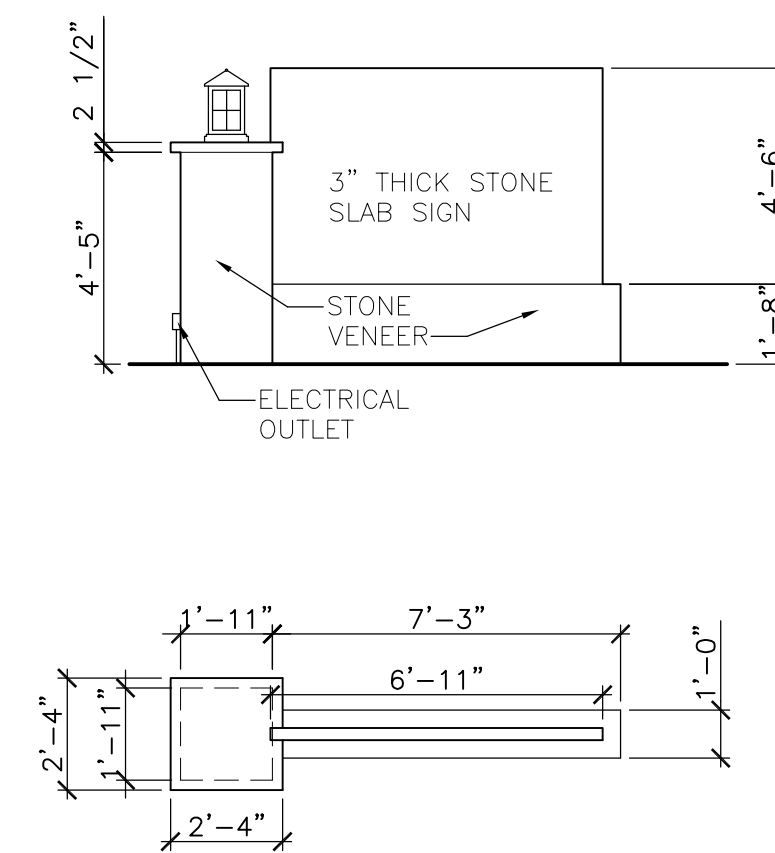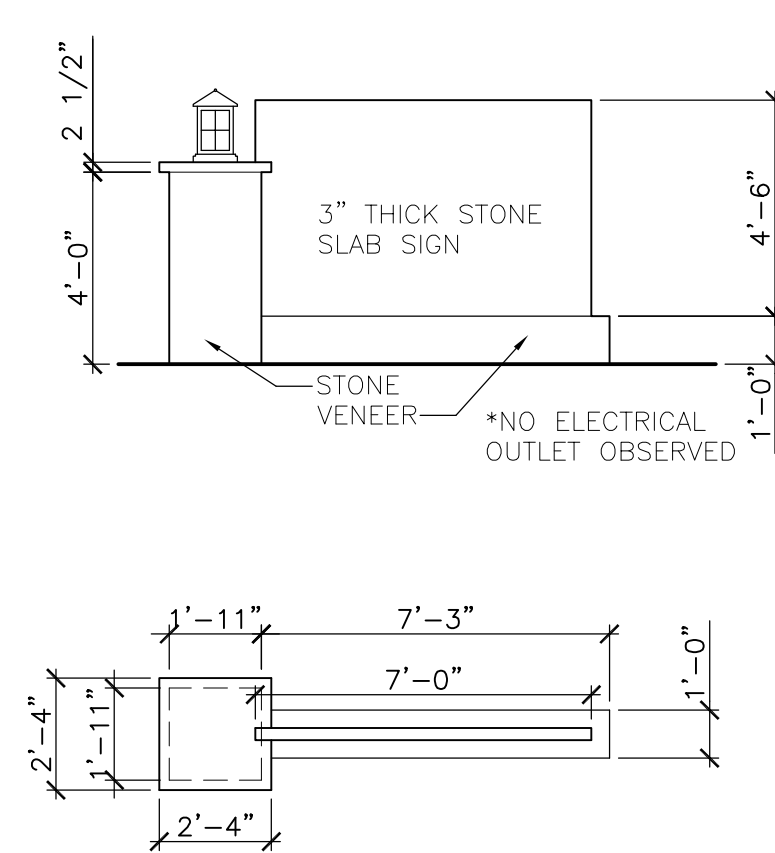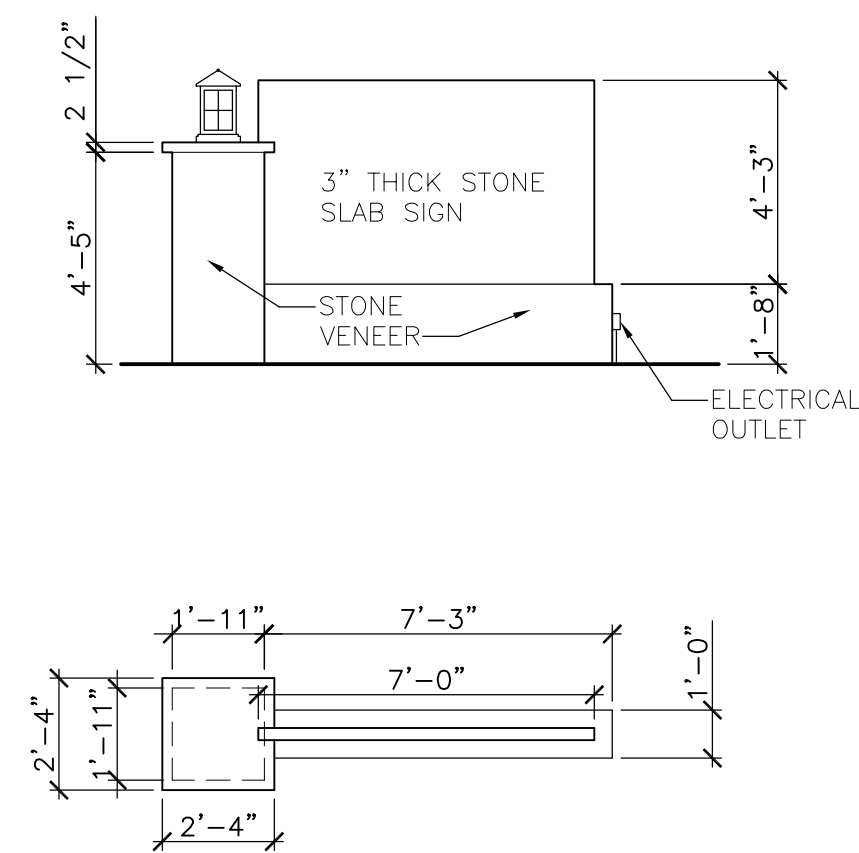

FACILITY DOCUMENTATION: VILLAGE GARDEN APARTMENTS

Fort Collins, CO 80525

[illegible]