

AS-BUILT DOCUMENTATION

WINDWARD SCHOOL APTS

LOS ANGELES, CA 90066



100% SUBMITTAL

DRAWING INDEX

- C-1 COVER SHEET | DRAWING INDEX
- SL SYMBOLS LEGEND
- AB-1 GROUND FLOOR PLAN
- AB-2 SECOND FLOOR PLAN
- AB-3 SECTIONS



VICINITY MAP
NTS

AREA DATA	
GROUND FLOOR	5,758 S.F. ±
SECOND FLOOR	6,800 S.F. ±
GRAND TOTAL	12,558 S.F. ±



ARCHITECTURAL AS BUILT
WINDWARD SCHOOL APTS

LOS ANGELES, CA 90066

01	100% SUBMISSION	SEE COVER SHEET
NO.	ISSUES REVISIONS	DATE
		SHEET TITLE

COVER SHEET

HL	PROJECT MANAGER
HL	PROJECT DIRECTOR
0	PROJECT NUMBER
	SCALE
MM	DRAWN BY
	SHEET NUMBER

C-1

SYMBOLS LEGEND

RCP

	EXHAUST VENT		TRACK LIGHT OR VANITY LIGHT
	CEILING MOUNTED LIGHT FIXTURE		WALL-MOUNTED LIGHT FIXTURE
	CEILING MOUNTED DIRECTIONAL LIGHT		EMERGENCY EXIT SIGN
	RECESSED CAN LIGHT		EMERGENCY EXIT LIGHT
	EYEBALL OR SMALL CAN LIGHT		EMERGENCY EXIT LIGHT W/ SIGN
	PENDANT LIGHT		LIGHTED STAIR SIGN
	INDIVIDUAL FLUOR. LAY-IN FIXTURE 4 BULB		FLOOD LIGHT
	INDIVIDUAL FLUOR. HANGING FIXTURE 2 BULB		PHOTO CELL
	INDIVIDUAL FLUOR. FLUSH MOUNT FIXTURE 4 BULB		CEILING FAN
	CAMERA		CEILING FAN W/ LIGHT KIT
	MOTION DET.		
	SUPPLY VENT		
	SUPPLY VENT		
	RETURN VENT		
	RETURN VENT		
	SPEAKER		

7-2-6
 CEILING HEIGHT AND TRIM 1'-2" ABOVE FLOOR BELOW WITH 6" CROWN MOULDING.
 NOTE: ALL CEILINGS NOT LABELED ARE PLASTER. CEILINGS SHOWN WITH A GRID ARE LAY IN ACOUSTICAL TILE..

ELECTRIC

	DATA OUTLET
	TELEPHONE JACK
	ELECTRIC SWITCH
	CABLE TELEVISION OUTLET
	DUPLEX RECEPTACLE OUTLET
	SPECIAL PURPOSE CONNECTION OR OUTLET
	QUADRUPLEX RECEPTACLE OUTLET
	FLOOR DUPLEX RECEPTACLE OUTLET
	ELECTRIC PANEL
	ELECTRIC METER
	BUTTON SWITCH
	DISCONNECT SWITCH
	GROUND/FLOOR LIGHT
	KEY PAD

FIRE PROTECTION




	FIRE EXTINGUISHER
	FIRE PULL
	FIRE ALARM (HORN/SRTOBE)
	SMOKE DETECTOR
	SMOKE ALARM SPEAKER
	SPRINKLER HEAD CEILING MOUNT
	SPRINKLER HEAD WALL MOUNT

MEP

	THERMOSTAT
	FLOOR DRAIN
	VALVE
	HOSE BIB
	WATER SUPPLY
	SUSPENDED GAS HEATER

MISC

	BOLLARD
	11-4-11/16 SPOT ELEVATION

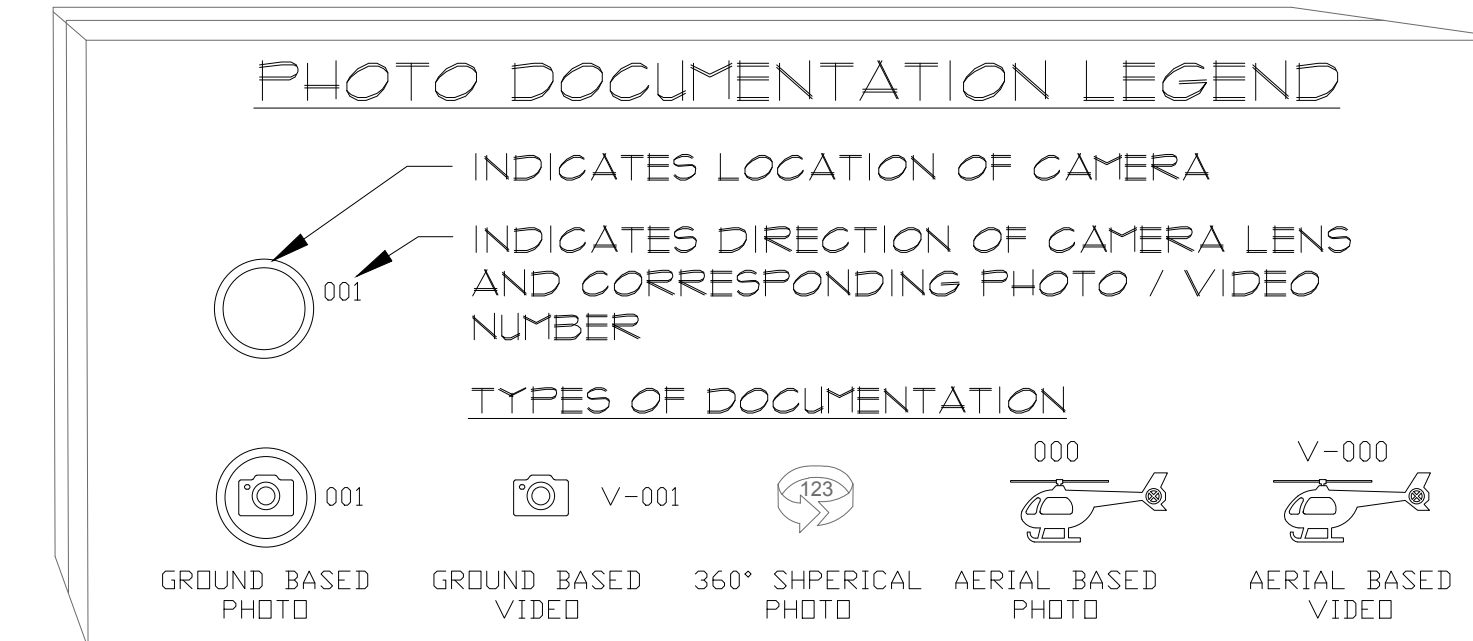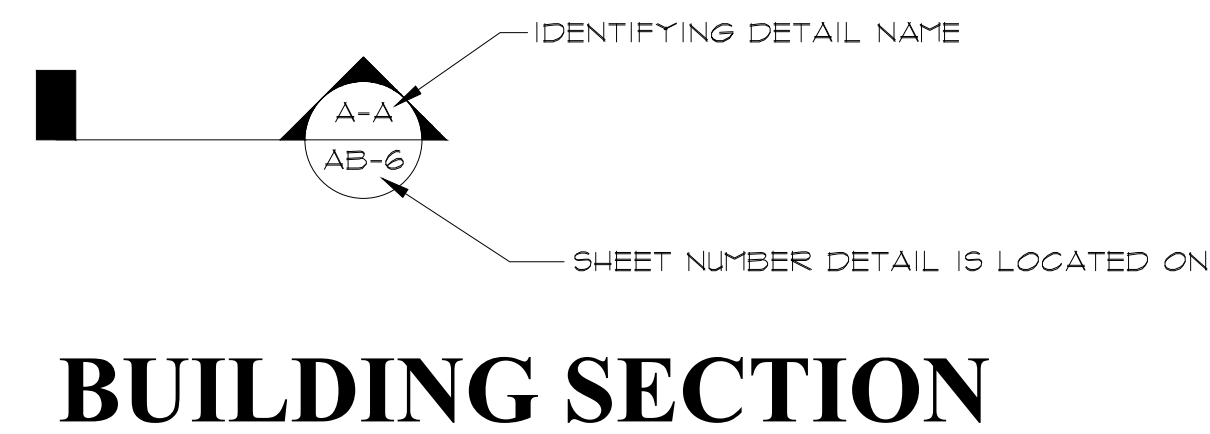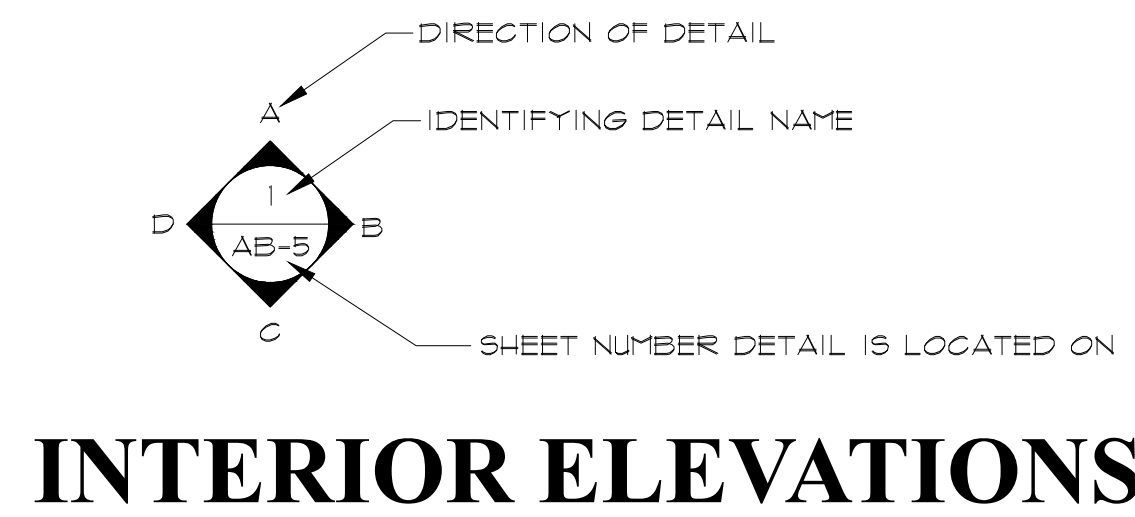


**ARCHITECTURAL AS BUILT
 WINDWARD SCHOOL APTS
 LOS ANGELES, CA 90066**

01	100% SUBMISSION	SEE COVER SHEET
NO.	ISSUES REVISIONS	DATE
SHEET TITLE		
HL	PROJECT MANAGER	
HL	PROJECT DIRECTOR	
O	PROJECT NUMBER	
NOT TO SCALE		SCALE
MM	DRAWN BY	
SHEET NUMBER		


SL

**ARCHITECTURAL AS BUILT
WINDWARD SCHOOL APTS**

LOS ANGELES, CA 90066

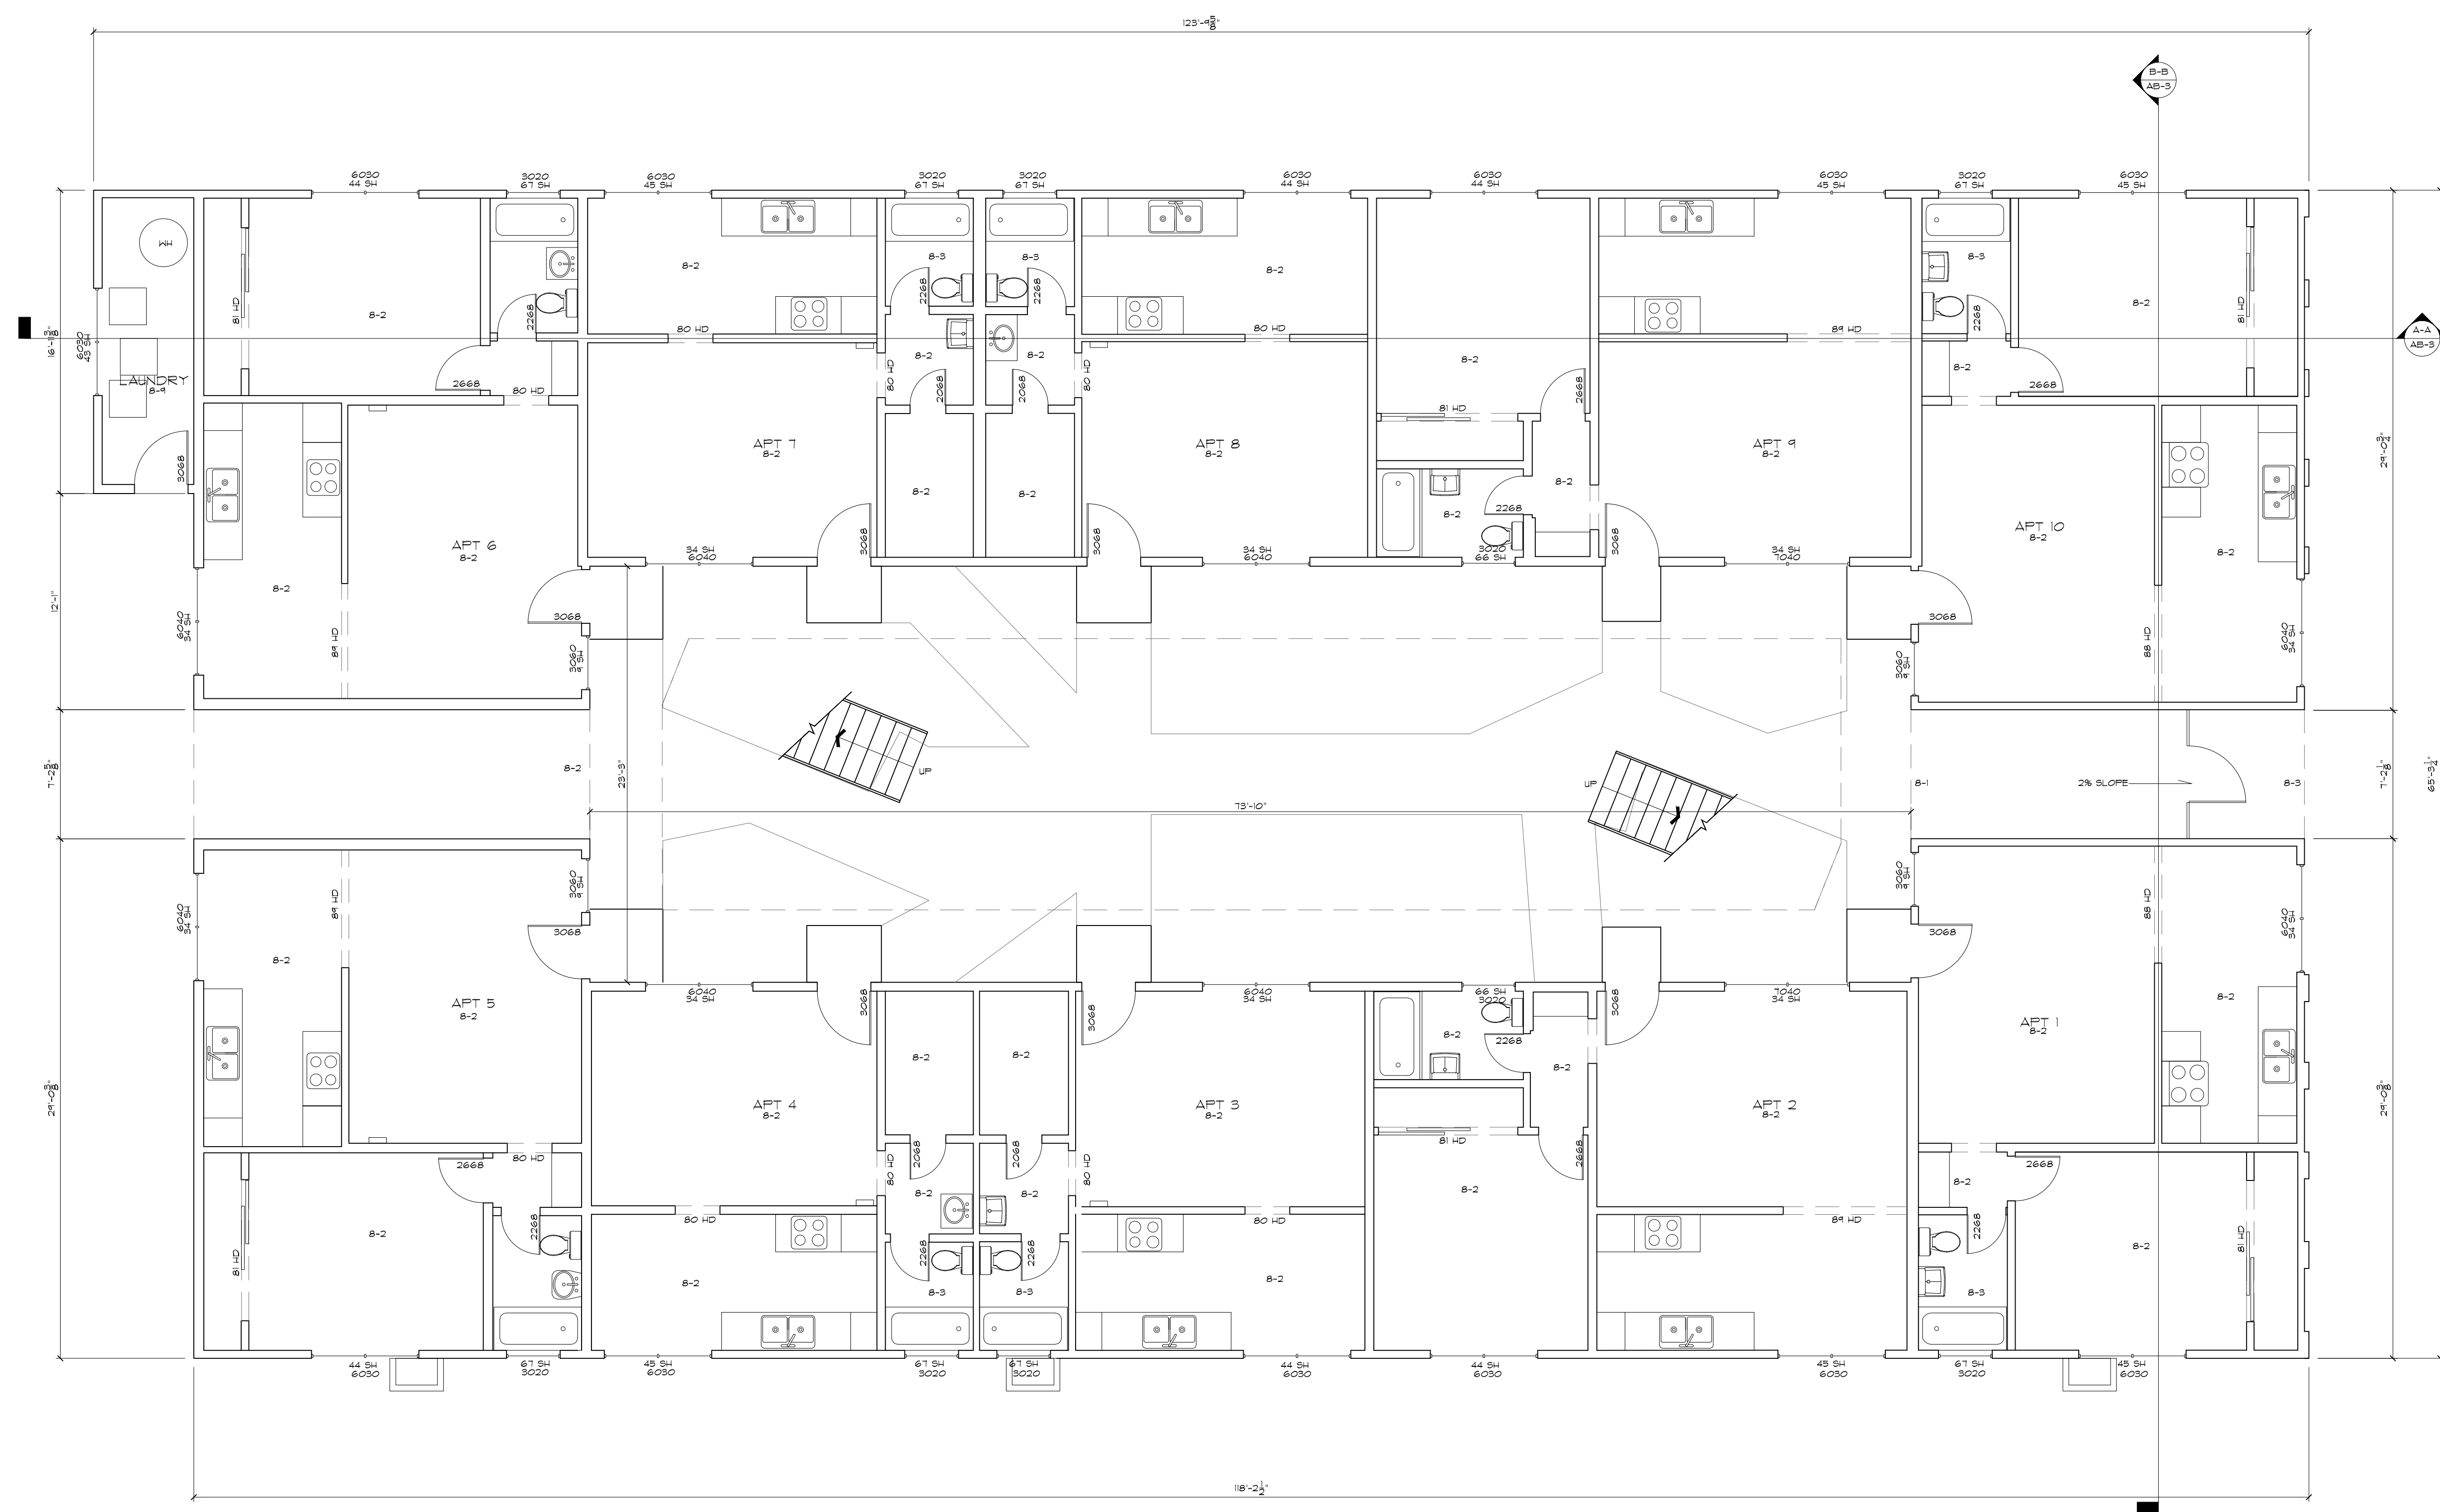

FIRST FLOOR PLAN

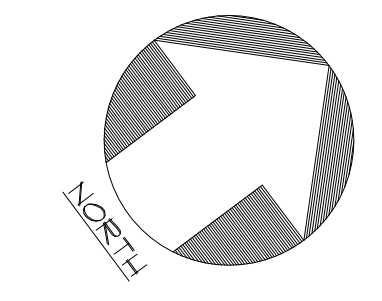


01	100% SUBMISSION	SEE COVER SHEET
NO.	ISSUES REVISIONS	DATE
		SHEET TITLE

HL	PROJECT MANAGER
HL	PROJECT DIRECTOR
0	PROJECT NUMBER
3/16"=1'-0"	SCALE
MM	DRAWN BY
	SHEET NUMBER


AB-1

**ARCHITECTURAL AS BUILT
WINDWARD SCHOOL APTS**

LOS ANGELES, CA 90066

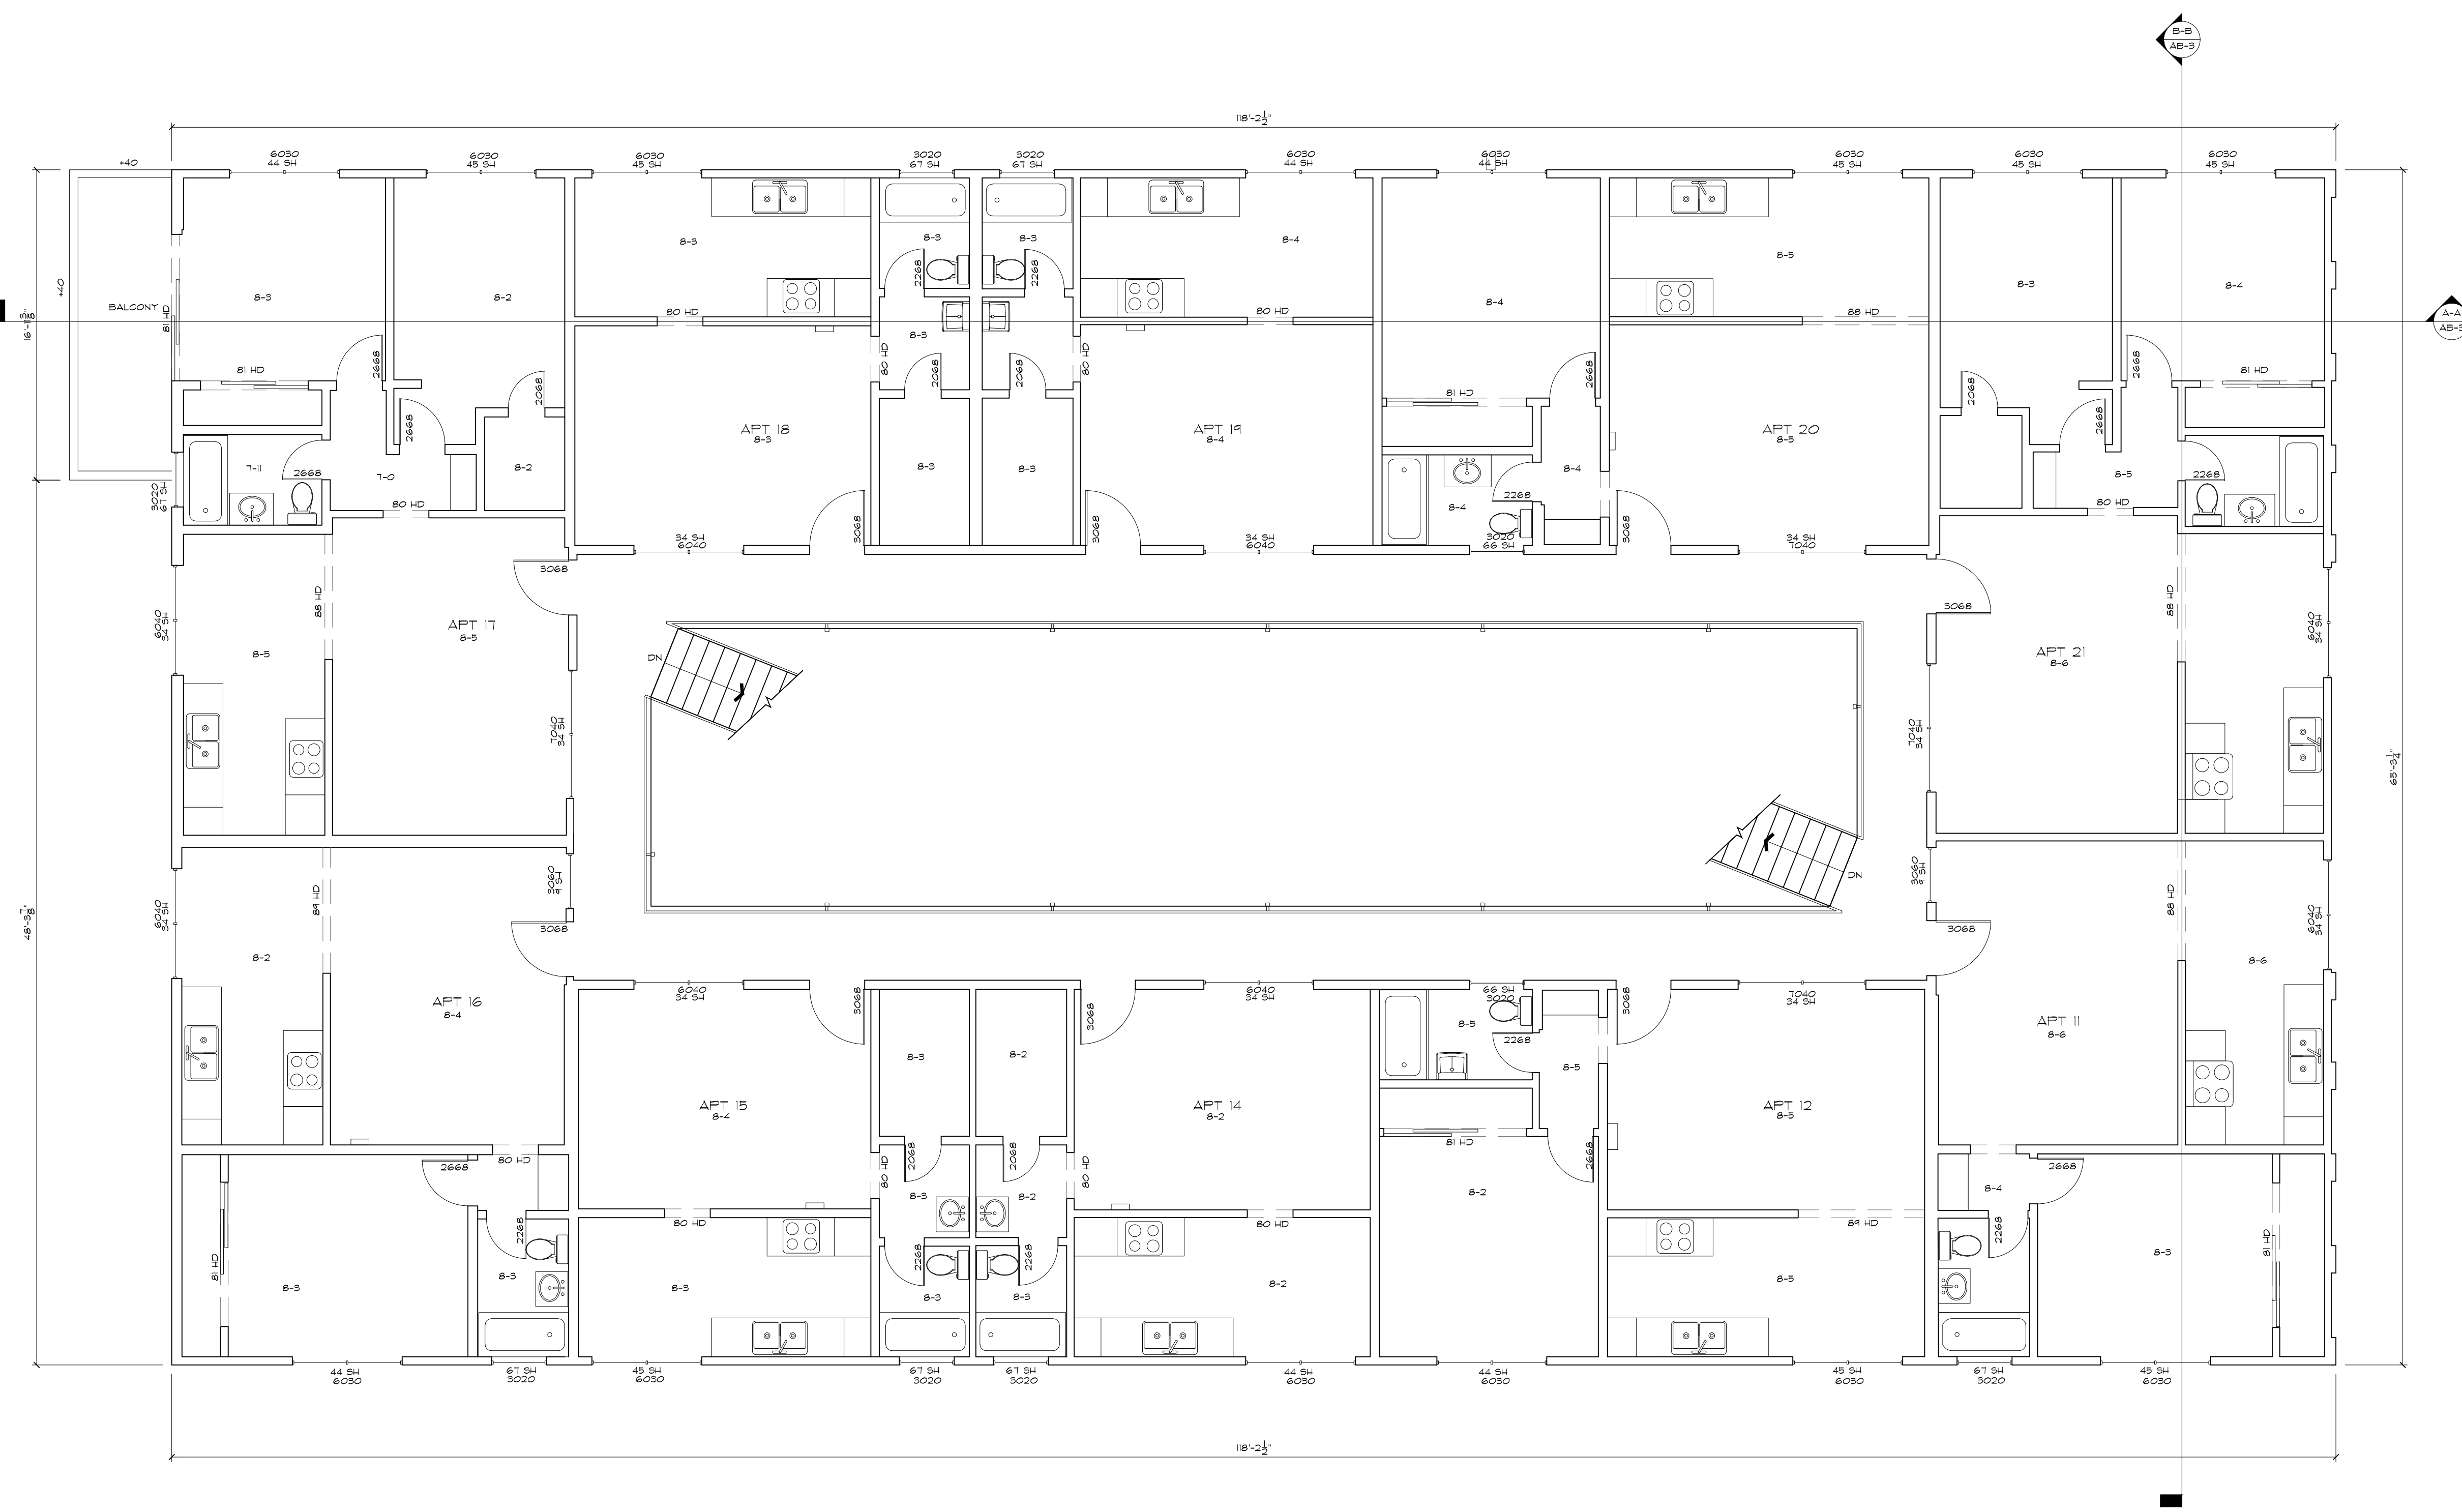

SECOND FLOOR PLAN

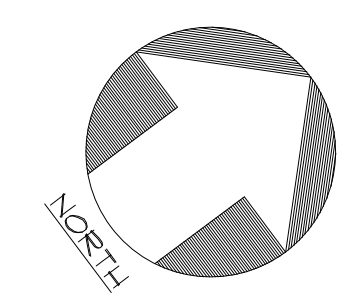


01	100% SUBMISSION	SEE COVER SHEET
NO.	ISSUES REVISIONS	DATE
		SHEET TITLE
HL		PROJECT MANAGER
HL		PROJECT DIRECTOR
0		PROJECT NUMBER
3/16"=1'-0"		SCALE
MM		DRAWN BY
		SHEET NUMBER


AB-2

**ARCHITECTURAL AS BUILT
 WINDWARD SCHOOL APTS**

LOS ANGELES, CA 90066

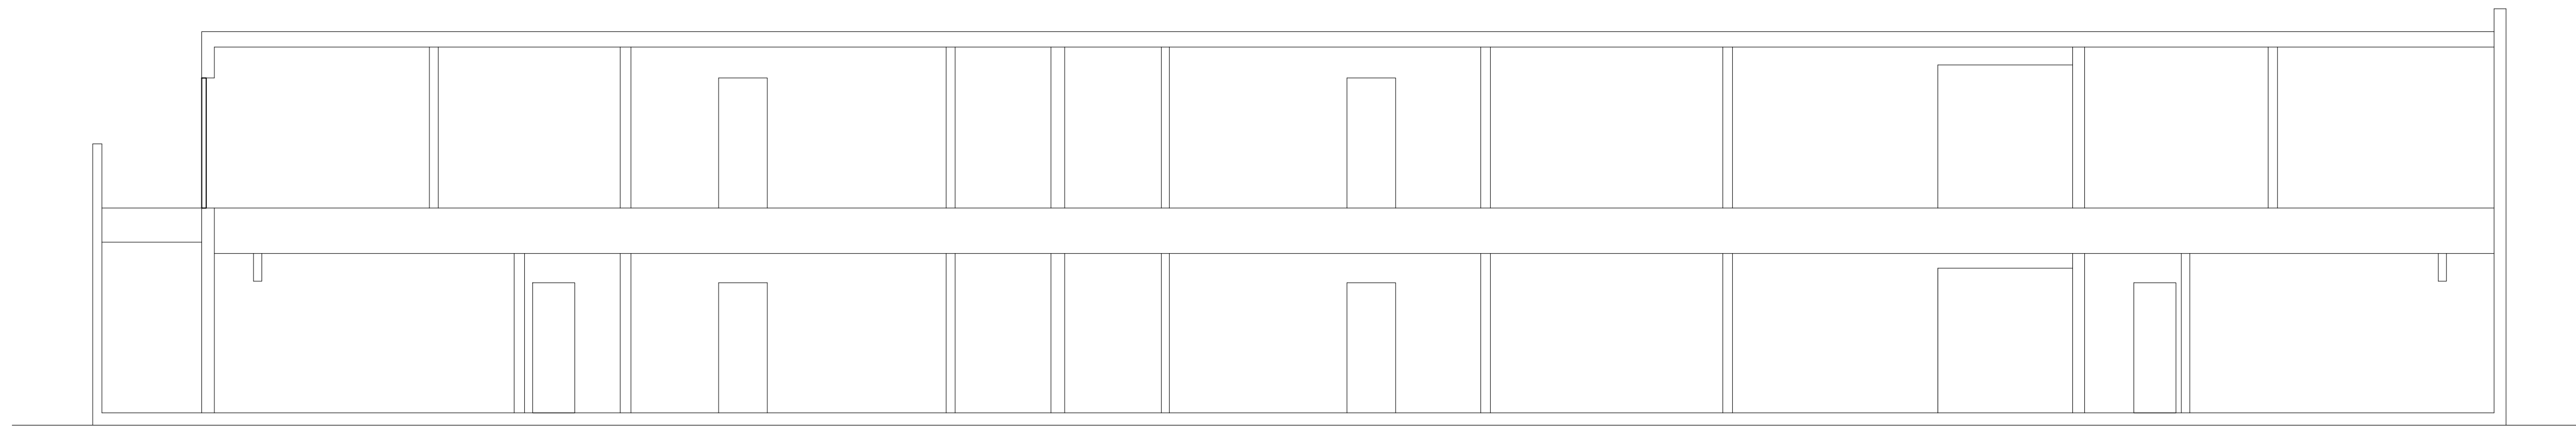

SECTION A-A

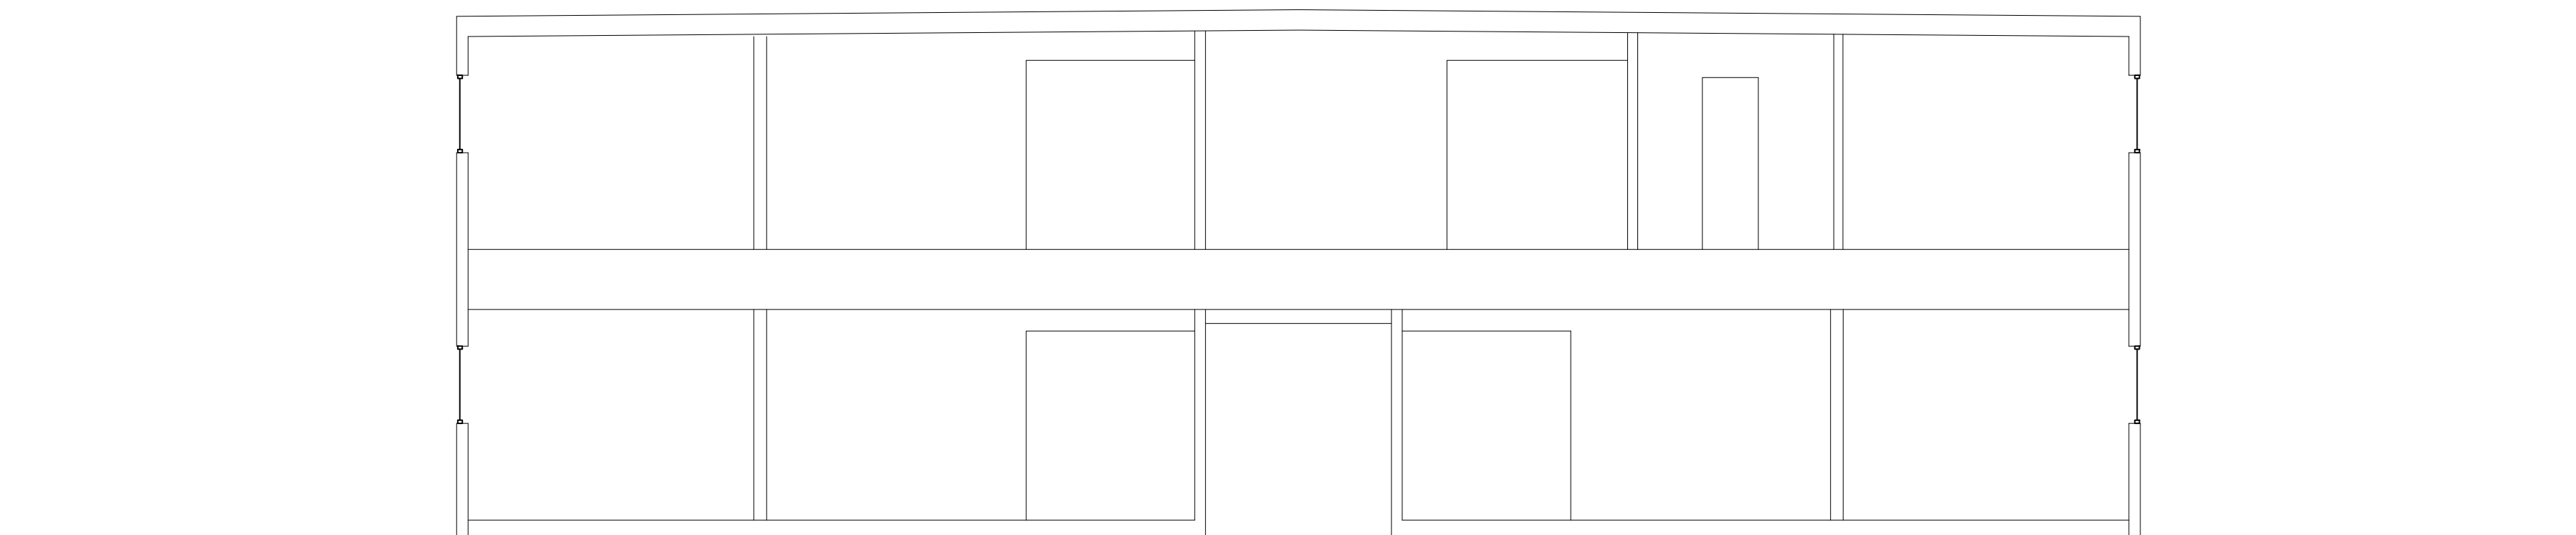

SECTION B-B

01	100% SUBMISSION	SEE COVER SHEET
NO.	ISSUES REVISIONS	DATE

SHEET TITLE

HL PROJECT MANAGER

HL PROJECT DIRECTOR

0 PROJECT NUMBER

3/16"=1'-0" SCALE

MM DRAWN BY

SHEET NUMBER

AB-3