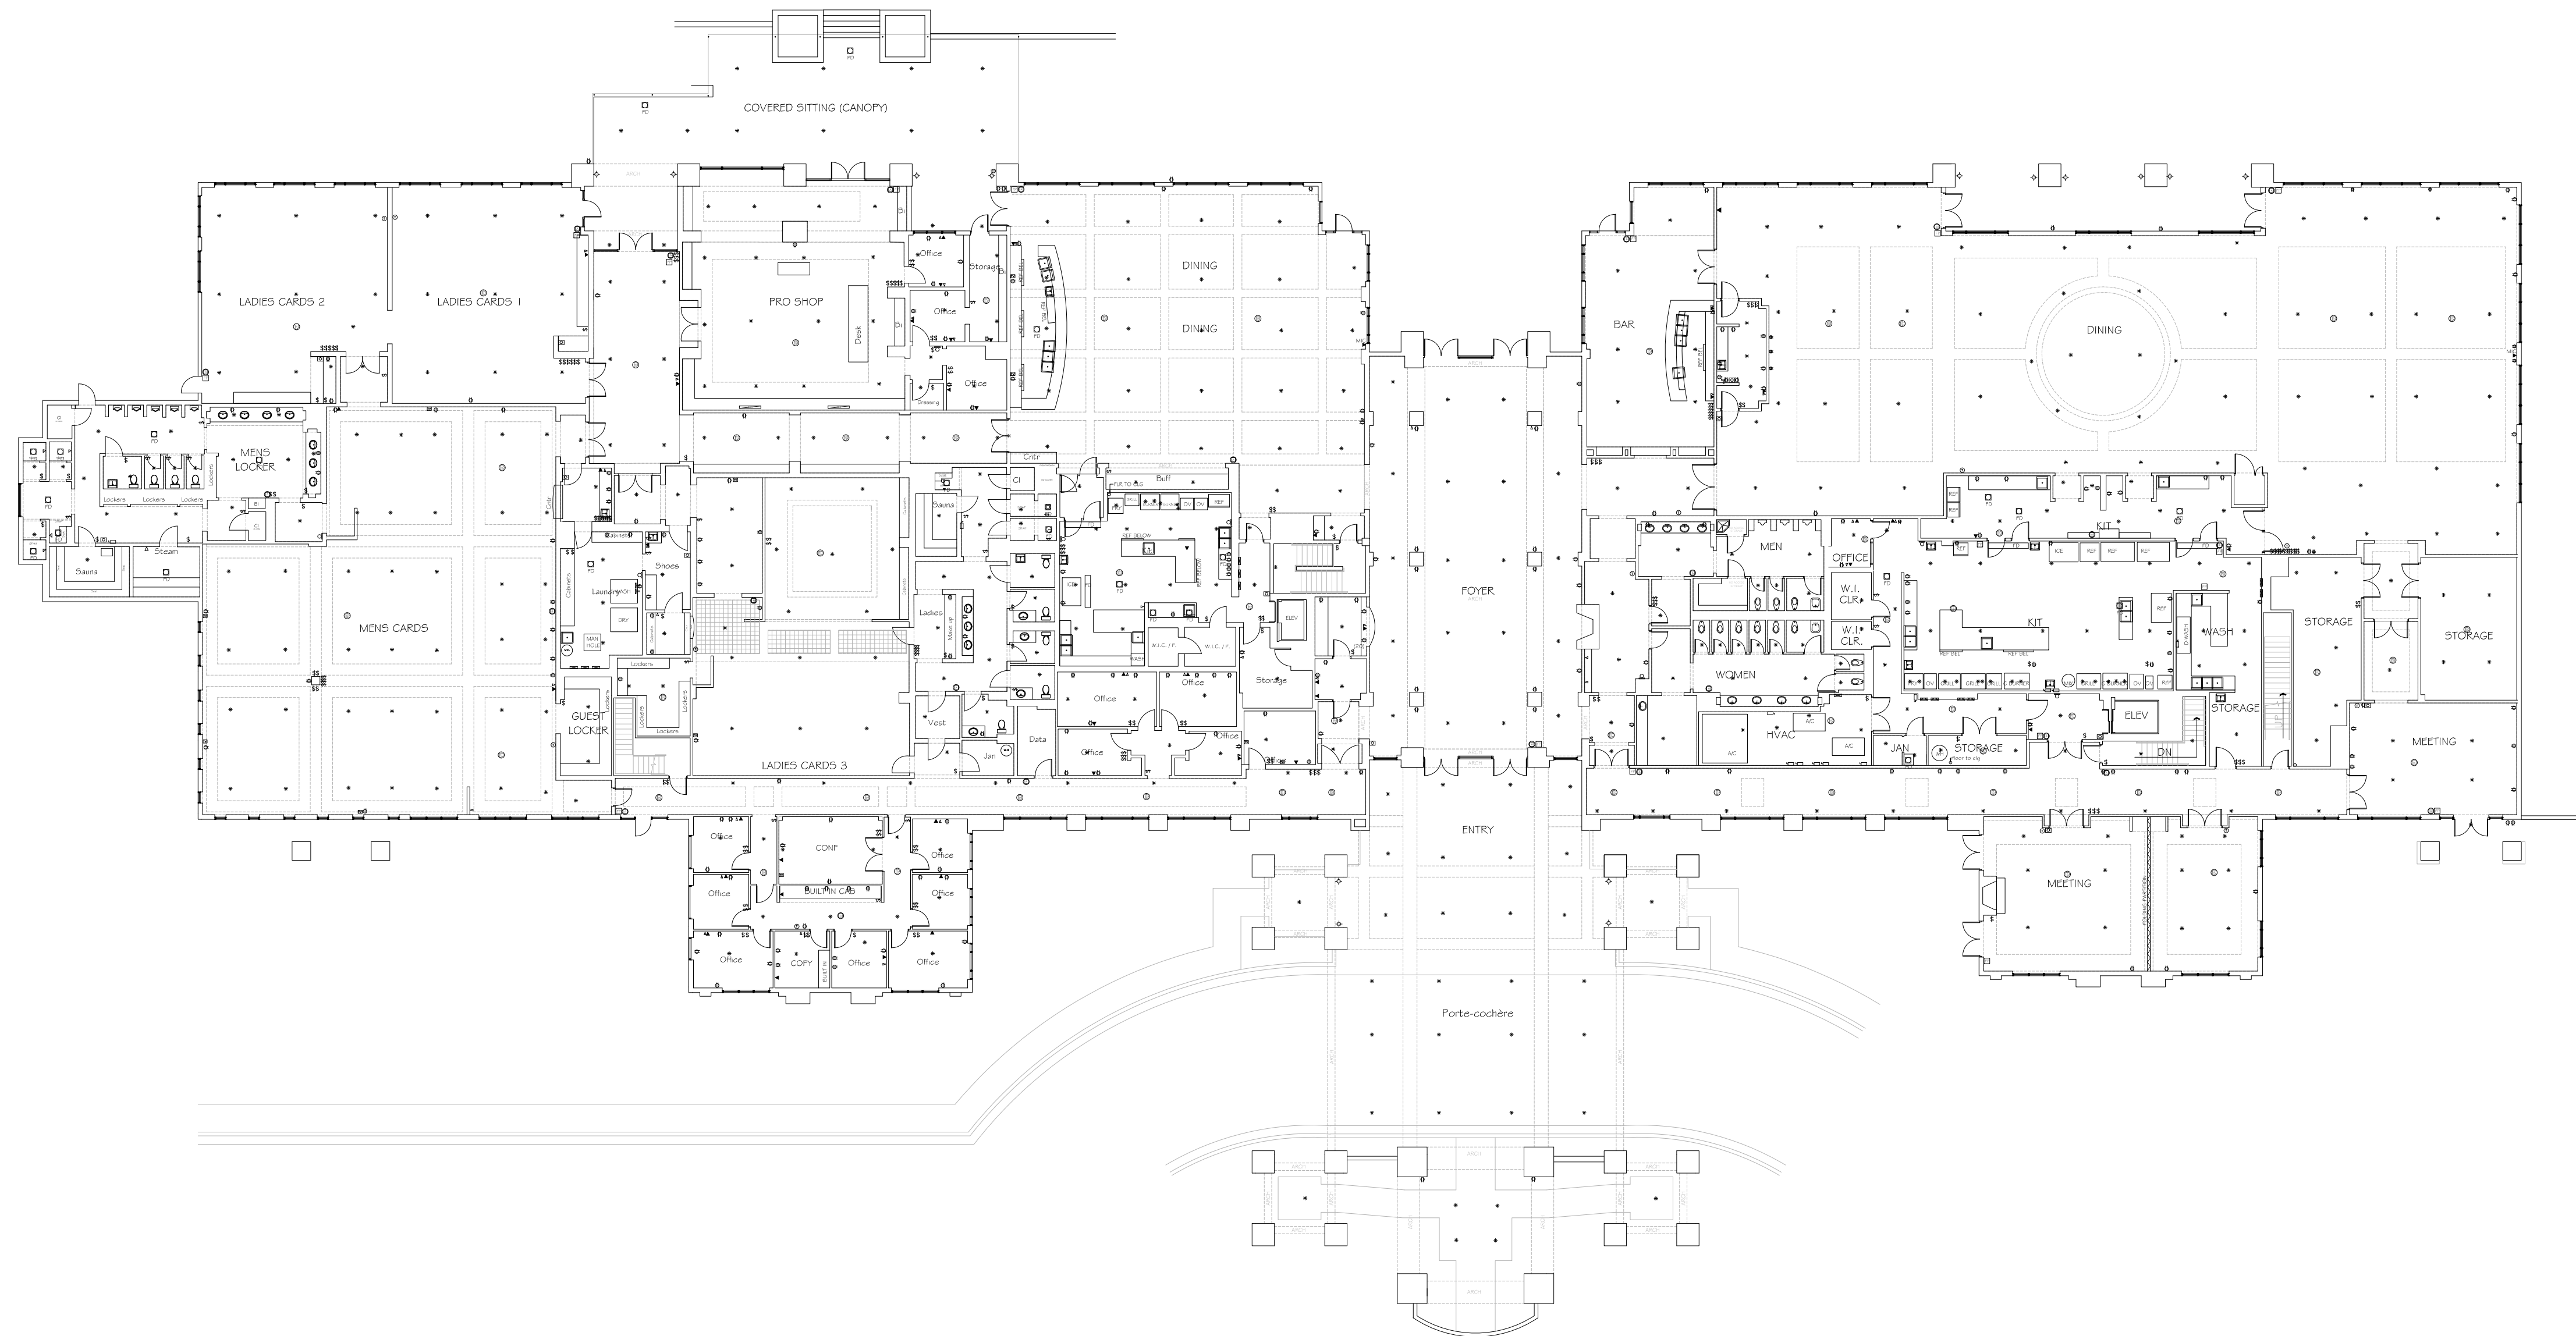


RCP		ELECTRIC	
	LOWEST VOLT		PLUG OUTLET
	LOWEST VOLT		TELEPHONE JACK
	LOWEST VOLT		TELEPHONE JACK
	NEEDED FOR LIGHT		TELEVISION
	INDUSTRIAL FLOOR		TOILET
	INDUSTRIAL FLOOR		TOILET PAPER
	INDUSTRIAL FLOOR		TOILET PAPER
AEC
CONSULTANTS, INC.

www.aecconsultantsinc.com

844.272.8458

© 2016 AEC CONSULTANTS, INC.

**AS BUILT DOCUMENTATION:
BALLENISLES COUNTRY CLUB**

01		
NO.	ISSUES REVISIONS	DATE
		SHEET TITLE
Fire Protection Plans (Main Level)		
XX		PROJECT MANAGER
HL		PROJECT DIRECTOR
XX,XX,XX		PROJECT NUMBER
AS NOTED		SCALE
XX		DRAWN BY
		SHEET NUMBER
XFP002		