

HIGHLAND PARK RESIDENCE


DALLAS TX 75205



100% SUBMITTAL

DRAWING INDEX

C-1	COVER SHEET DRAWING INDEX
SL	SYMBOLS LEGEND
AB-1	FIRST FLOOR PLAN
AB-2	SECOND AND THIRD FLOOR PLAN
AB-3	FIRST FLOOR RCP
AB-4	SECOND AND THIRD FLOOR RCP
AB-5	ROOF PLAN
AB-6	ELEVATIONS
AB-7	ELEVATIONS

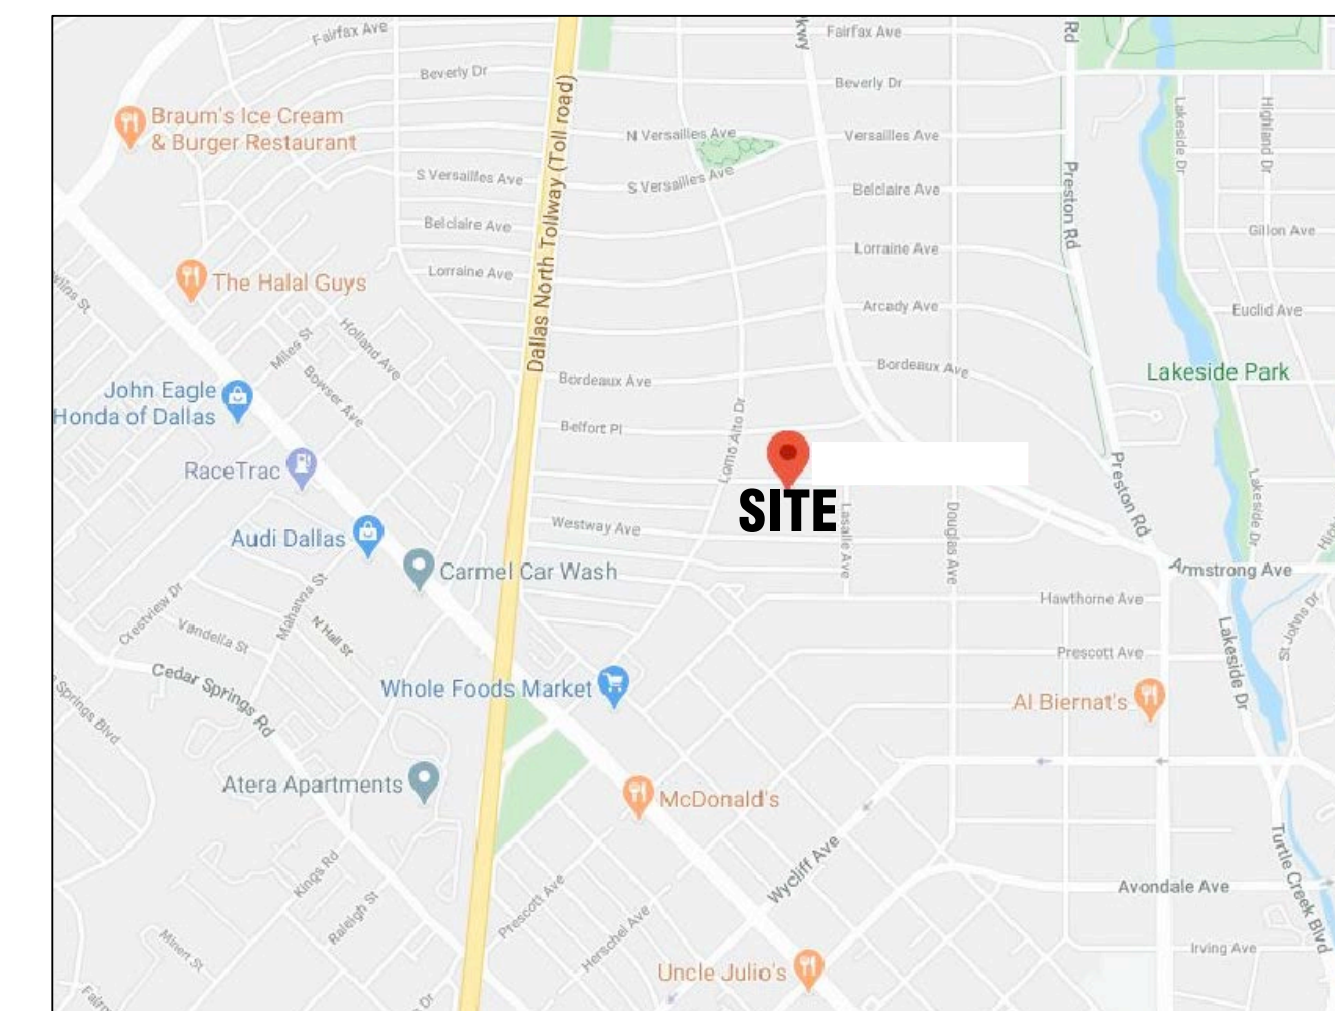

 **VICINITY MAP**
NTS

<u>AREA DATA</u>	
FIRST FLOOR	2,751 S.F. ±
SECOND FLOOR	3,170 S.F. ±
THIRD FLOOR	1,013 S.F. ±
PATIO	646 S.F. ±
GARAGE PARKING	773 S.F. ±
GARAGE BASEMENT	773 S.F. ±
GARAGE SECOND FLOOR	773 S.F. ±
TOTAL HOUSE	7,580 S.F. ±
TOTAL GARAGE	2,319 S.F. ±
GRAND TOTAL	9,899 S.F. ±



© 2020 AEC CONSULTANTS INC

**ARCHITECTURAL AS BUILT
HIGHLAND PARK RESIDENCE**

No.	ISSUES REVISIONS	DATE
		SHEET TITLE
COVER		
H/L	PROJECT MANAGER	
H/L	PROJECT DIRECTOR	
012317-1	PROJECT NUMBER	
	SCALE	
MM	DRAWN BY	
		SHEET NUMBER
C-1		

SYMBOLS LEGEND

RCP

	EXHAUST VENT		TRACK LIGHT OR VANITY LIGHT
	CEILING MOUNTED LIGHT FIXTURE		WALL-MOUNTED LIGHT FIXTURE
	CEILING MOUNTED DIRECTIONAL LIGHT		EMERGENCY EXIT SIGN
	RECESSED CAN LIGHT		EMERGENCY EXIT LIGHT
	EYEBALL OR SMALL CAN LIGHT		EMERGENCY EXIT LIGHT W/ SIGN
	PENDANT LIGHT		LIGHTED STAIR SIGN
	INDIVIDUAL FLUOR. LAY-IN FIXTURE 4 BULB		FLOOD LIGHT
	INDIVIDUAL FLUOR. HANGING FIXTURE 2 BULB		PHOTO CELL
	INDIVIDUAL FLUOR. FLUSH MOUNT FIXTURE 4 BULB		CEILING FAN
	CAMERA		CEILING FAN W/ LIGHT KIT
	MOTION DET.	7-2-6 CEILING HEIGHT AND TRIM 7'-2" ABOVE FLOOR BELOW WITH 6" CROWN MOULDING. NOTE: ALL CEILINGS NOT LABELED ARE PLASTER. CEILINGS SHOWN WITH A GRID ARE LAY IN ACOUSTICAL TILE..	
	SUPPLY VENT		
	SUPPLY VENT		
	RETURN VENT		
	RETURN VENT		
	SPEAKER		JUNCTION BOX

ELECTRIC

	DATA OUTLET
	TELEPHONE/DATA
	ELECTRIC SWITCH
	CABLE TELEVISION OUTLET
	DUPLEX RECEPTACLE OUTLET
	SPECIAL PURPOSE CONNECTION OR OUTLET
	QUADRUPLIX RECEPTACLE OUTLET
	FLOOR DUPLEX RECEPTACLE OUTLET
	ELECTRIC PANEL
	ELECTRIC METER
	BUTTON SWITCH
	DISCONNECT SWITCH
	GROUND/FLOOR LIGHT
	KEY PAD
	RECESSED WALL MOUNTED FLOOR LIGHTING.
	BUTTON SWITCH

FIRE PROTECTION

	FIRE PULL
	FIRE ALARM (HORN/SRTOBE)
	SMOKE DETECTOR
	SMOKE ALARM SPEAKER
	SPRINKLER HEAD CEILING MOUNT
	SPRINKLER HEAD WALL MOUNT

MEP

	THERMOSTAT
	FLOOR DRAIN
	VALVE
	HOSE BIB
	WATER VALVE
	SUSPENDED GAS HEATER
	HVAC FLOOR VENT

MISC

	BOLLARD
	SPOT ELEVATION

7-2-6

CEILING HEIGHT AND TRIM
7'-2" ABOVE FLOOR BELOW
WITH 6" CROWN MOULDING.
NOTE: ALL CEILINGS NOT
LABELED ARE PLASTER.
CEILINGS SHOWN WITH A GRID
ARE LAY IN ACOUSTICAL TILE..

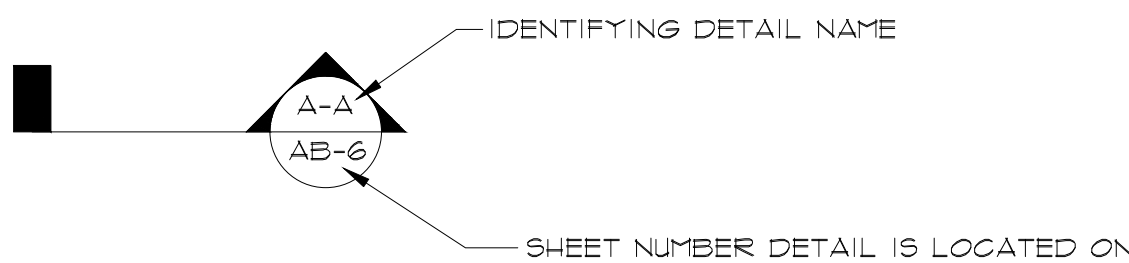
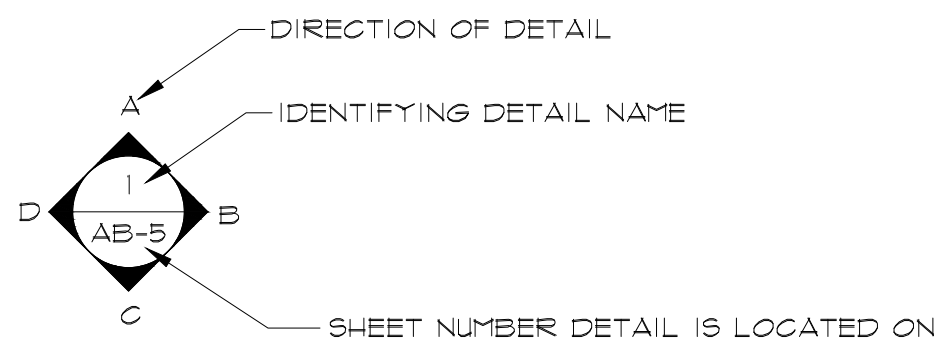


PHOTO DOCUMENTATION LEGEND

- INDICATES LOCATION OF CAMERA
- INDICATES DIRECTION OF CAMERA LENS AND CORRESPONDING PHOTO / VIDEO NUMBER

TYPES OF DOCUMENTATION

	GROUND BASED PHOTO		GROUND BASED VIDEO		360° SPHERICAL PHOTO		AERIAL BASED PHOTO		AERIAL BASED VIDEO
--	--------------------	--	--------------------	--	----------------------	--	--------------------	--	--------------------

ARCHITECTURAL AS BUILT
HIGHLAND PARK RESIDENCE
DALLAS TX 75205

NO. ISSUES | REVISIONS DATE

SHEET TITLE

SYMBOLS

HL PROJECT MANAGER

HL PROJECT DIRECTOR

012317-1 PROJECT NUMBER


NOT TO SCALE SCALE

MM DRAWN BY


SL

SHEET NUMBER


ARCHITECTURAL AS BUILT
HIGHLAND PARK RESIDENCE
DALLAS TX 75205

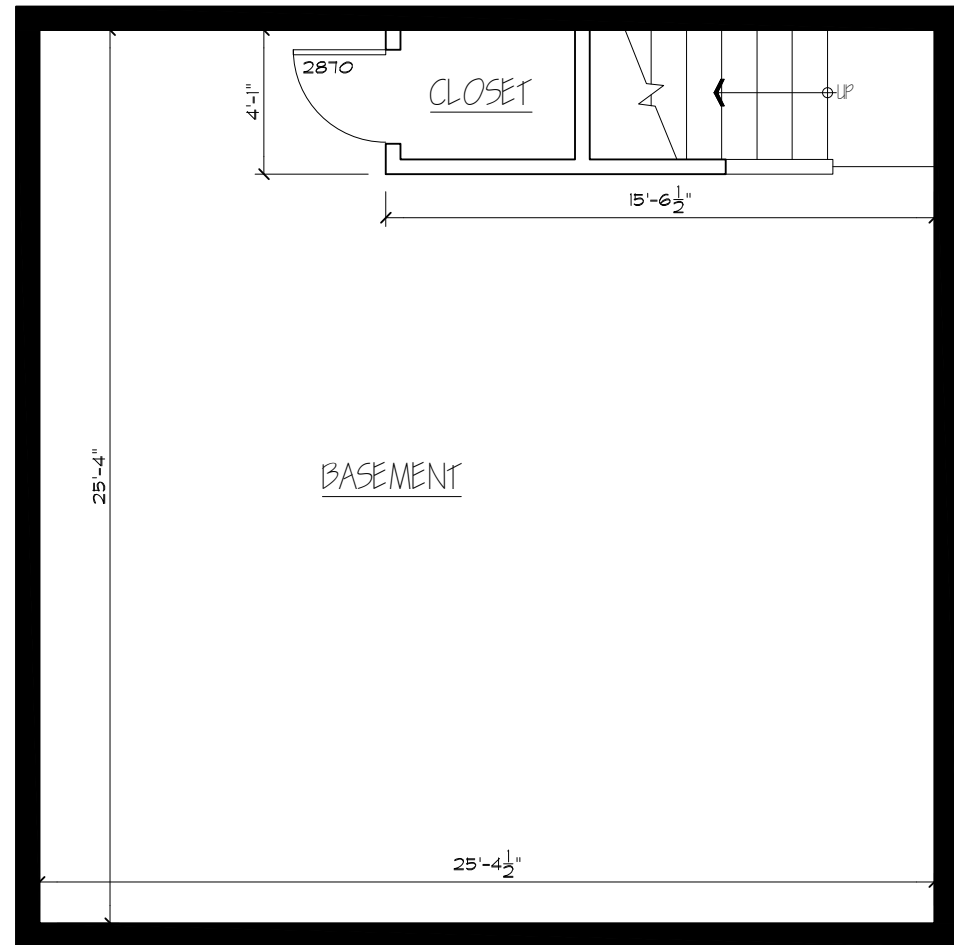

GARAGE BASEMENT

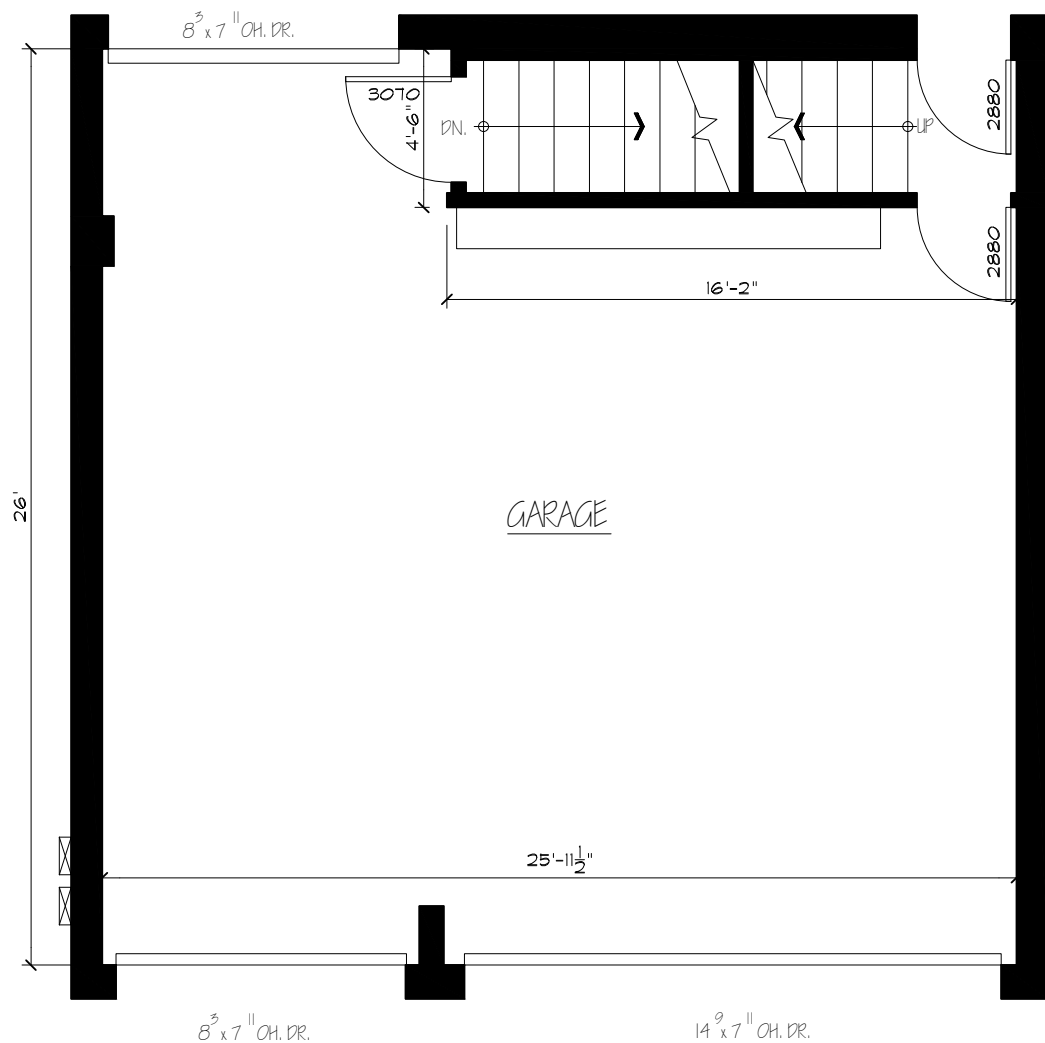

FIRST FLOOR PLAN

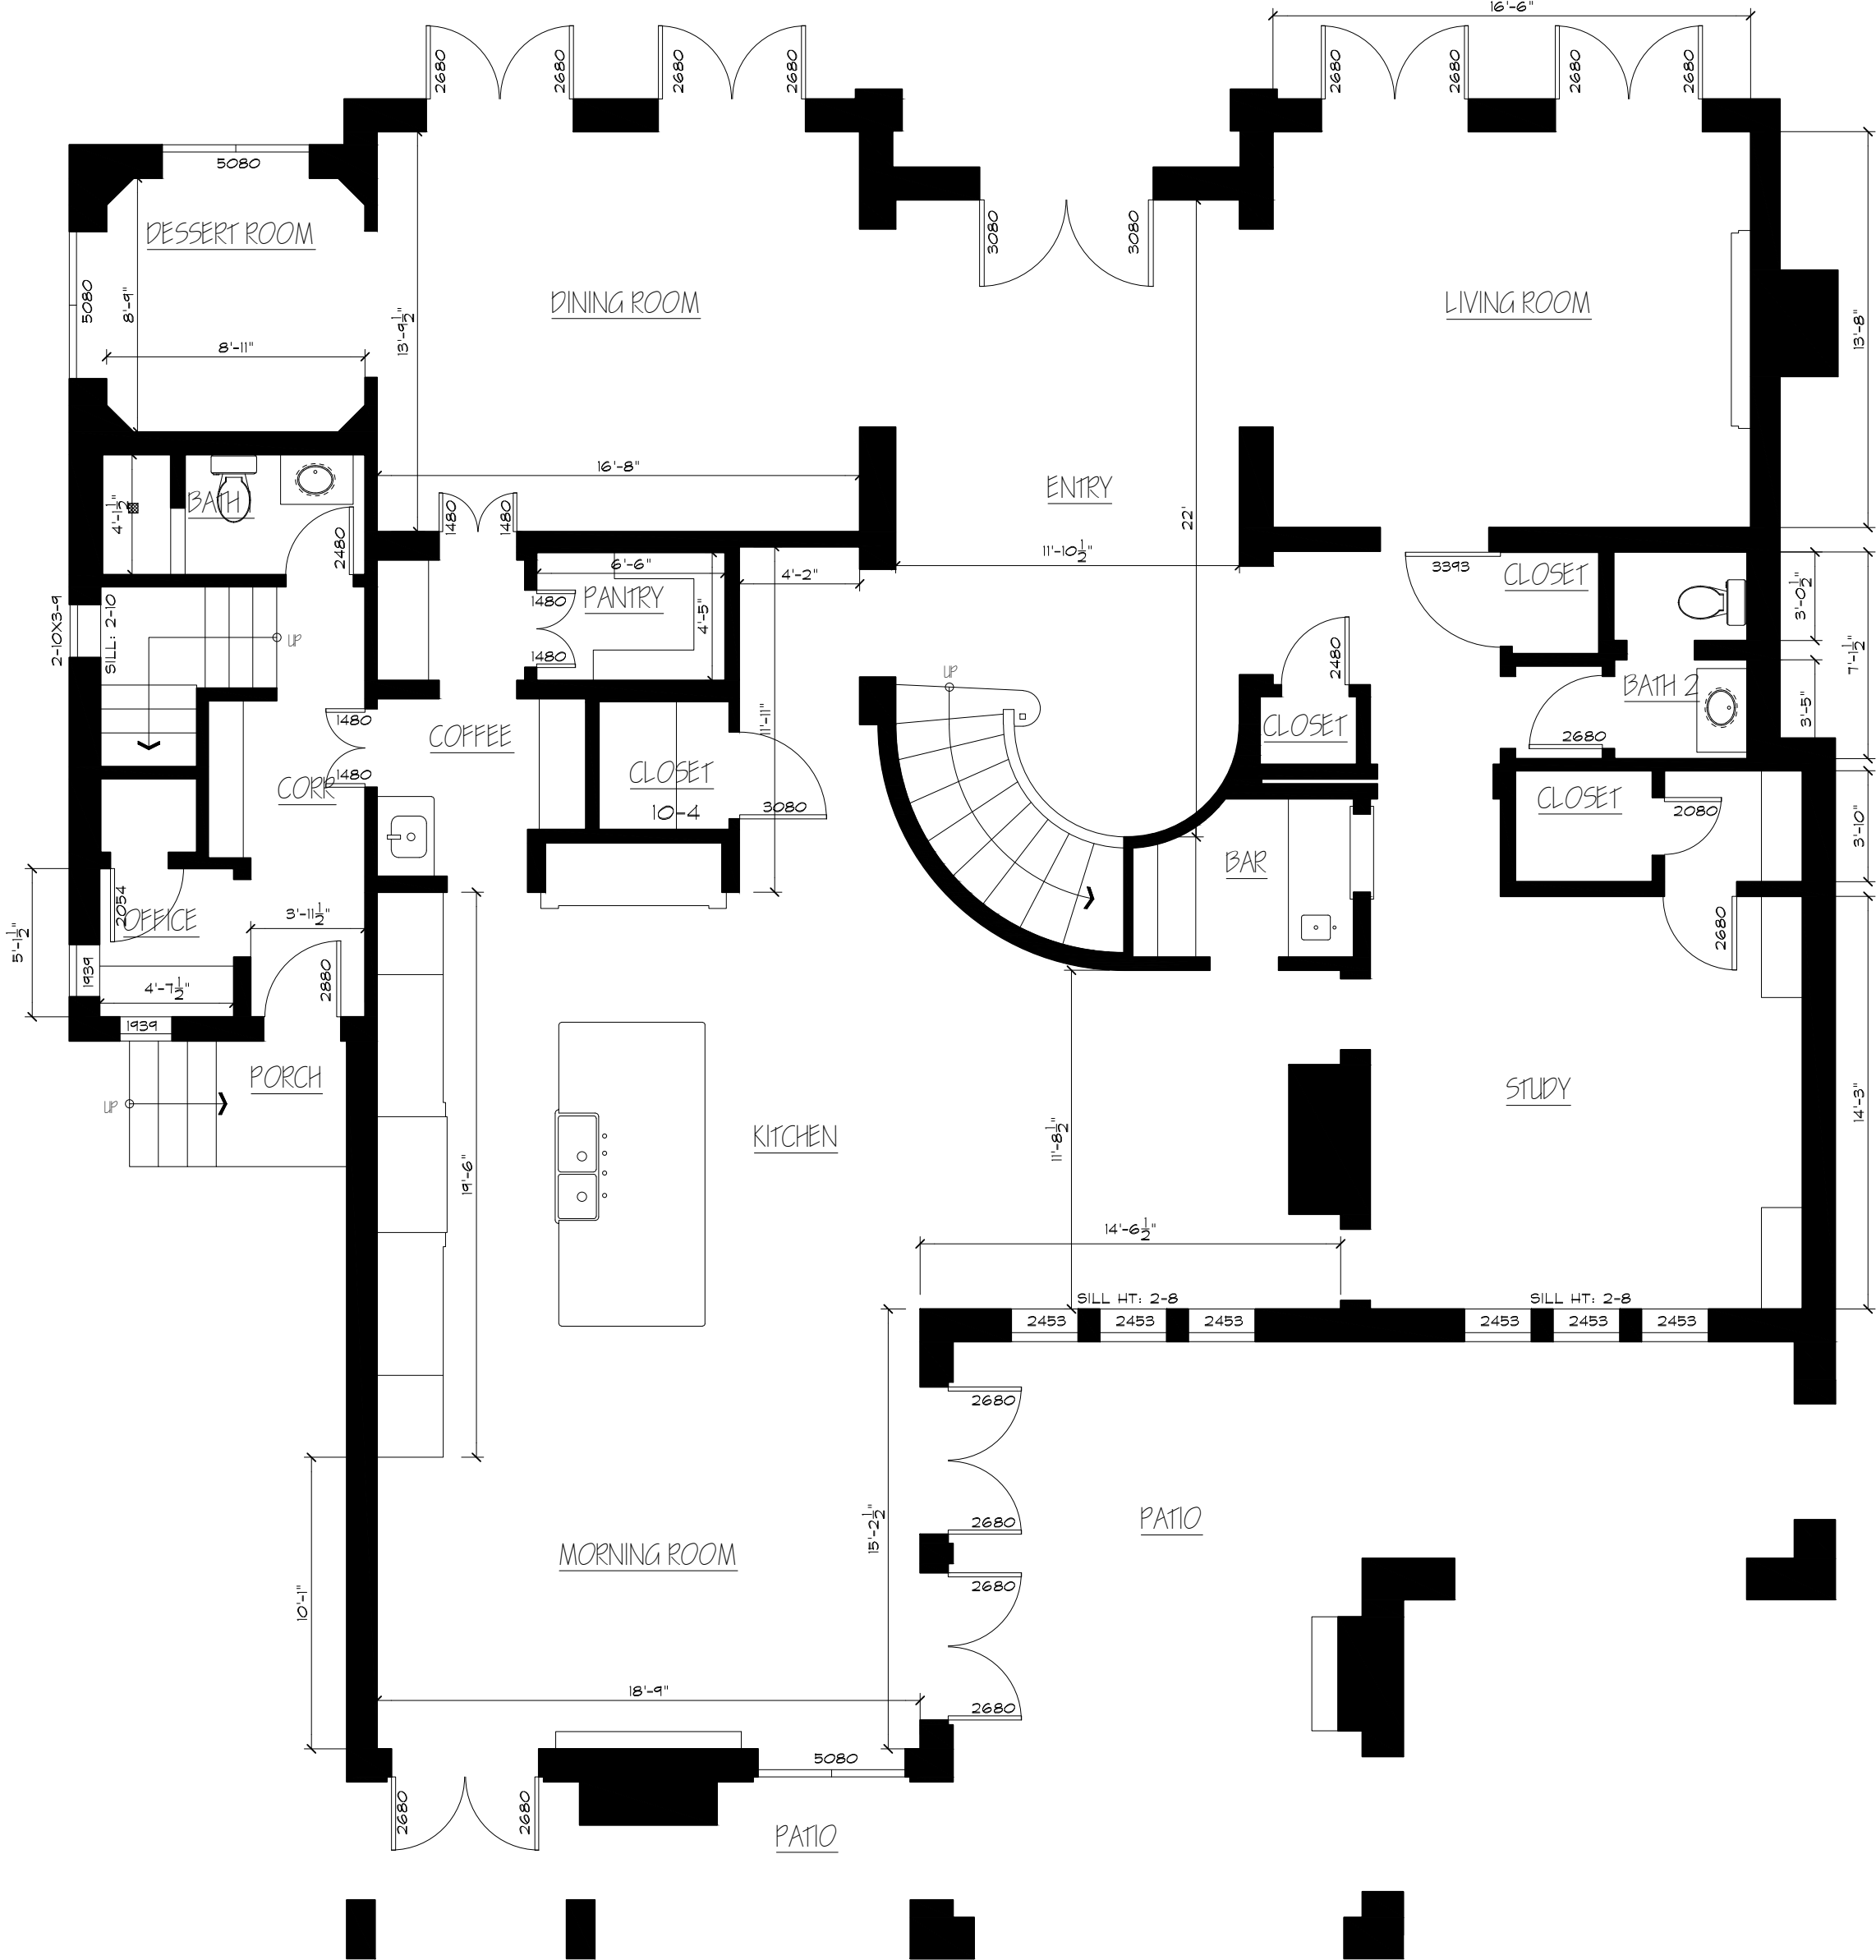


FINISH SCHEDULE

ROOM NAME	FLOOR	WALLS	CEILING	NOTES
GARAGE	BARE CONC	PAINTED DRYWALL	PAINTED DRYWALL	
GARAGE BASEMENT	PAINTED CONC	PAINTED CONCRETE	PAINTED METAL	
KITCHEN/MORNING ROOM	STAINED WOOD	PAINTED DRYWALL	PAINTED DRYWALL	
STUDY	STAINED WOOD	PAINTED DRYWALL	PAINTED DRYWALL	
BATH 1	TILE	PAINTED DRYWALL	PAINTED DRYWALL	TILE WAINSCOT UP TO 36"
OFFICE	STAINED WOOD	WALL PAPER	WALL PAPER	
PANTRY	STAINED WOOD	PAINTED DRYWALL	PAINTED DRYWALL	
DINING ROOM	STAINED WOOD	PAINTED DRYWALL	PAINTED DRYWALL	WAINSCOT UP TO 36"
DESSERT ROOM	STAINED WOOD	PAINTED DRYWALL	PAINTED DRYWALL	
ENTRY	TILE	PAINTED DRYWALL	PAINTED DRYWALL	
LIVING ROOM	STAINED WOOD	PAINTED DRYWALL	PAINTED DRYWALL	
BATH 2	STAINED WOOD	PAINTED DRYWALL	PAINTED DRYWALL	TILE WAINSCOT UP TO 36"

FIRST FLOOR
PLAN

HL	PROJECT MANAGER
HL	PROJECT DIRECTOR
012317-1	PROJECT NUMBER
3/16"=1'-0"	SCALE
MM	DRAWN BY
	SHEET NUMBER


ARCHITECTURAL AS BUILT
HIGHLAND PARK RESIDENCE
DALLAS TX 75205

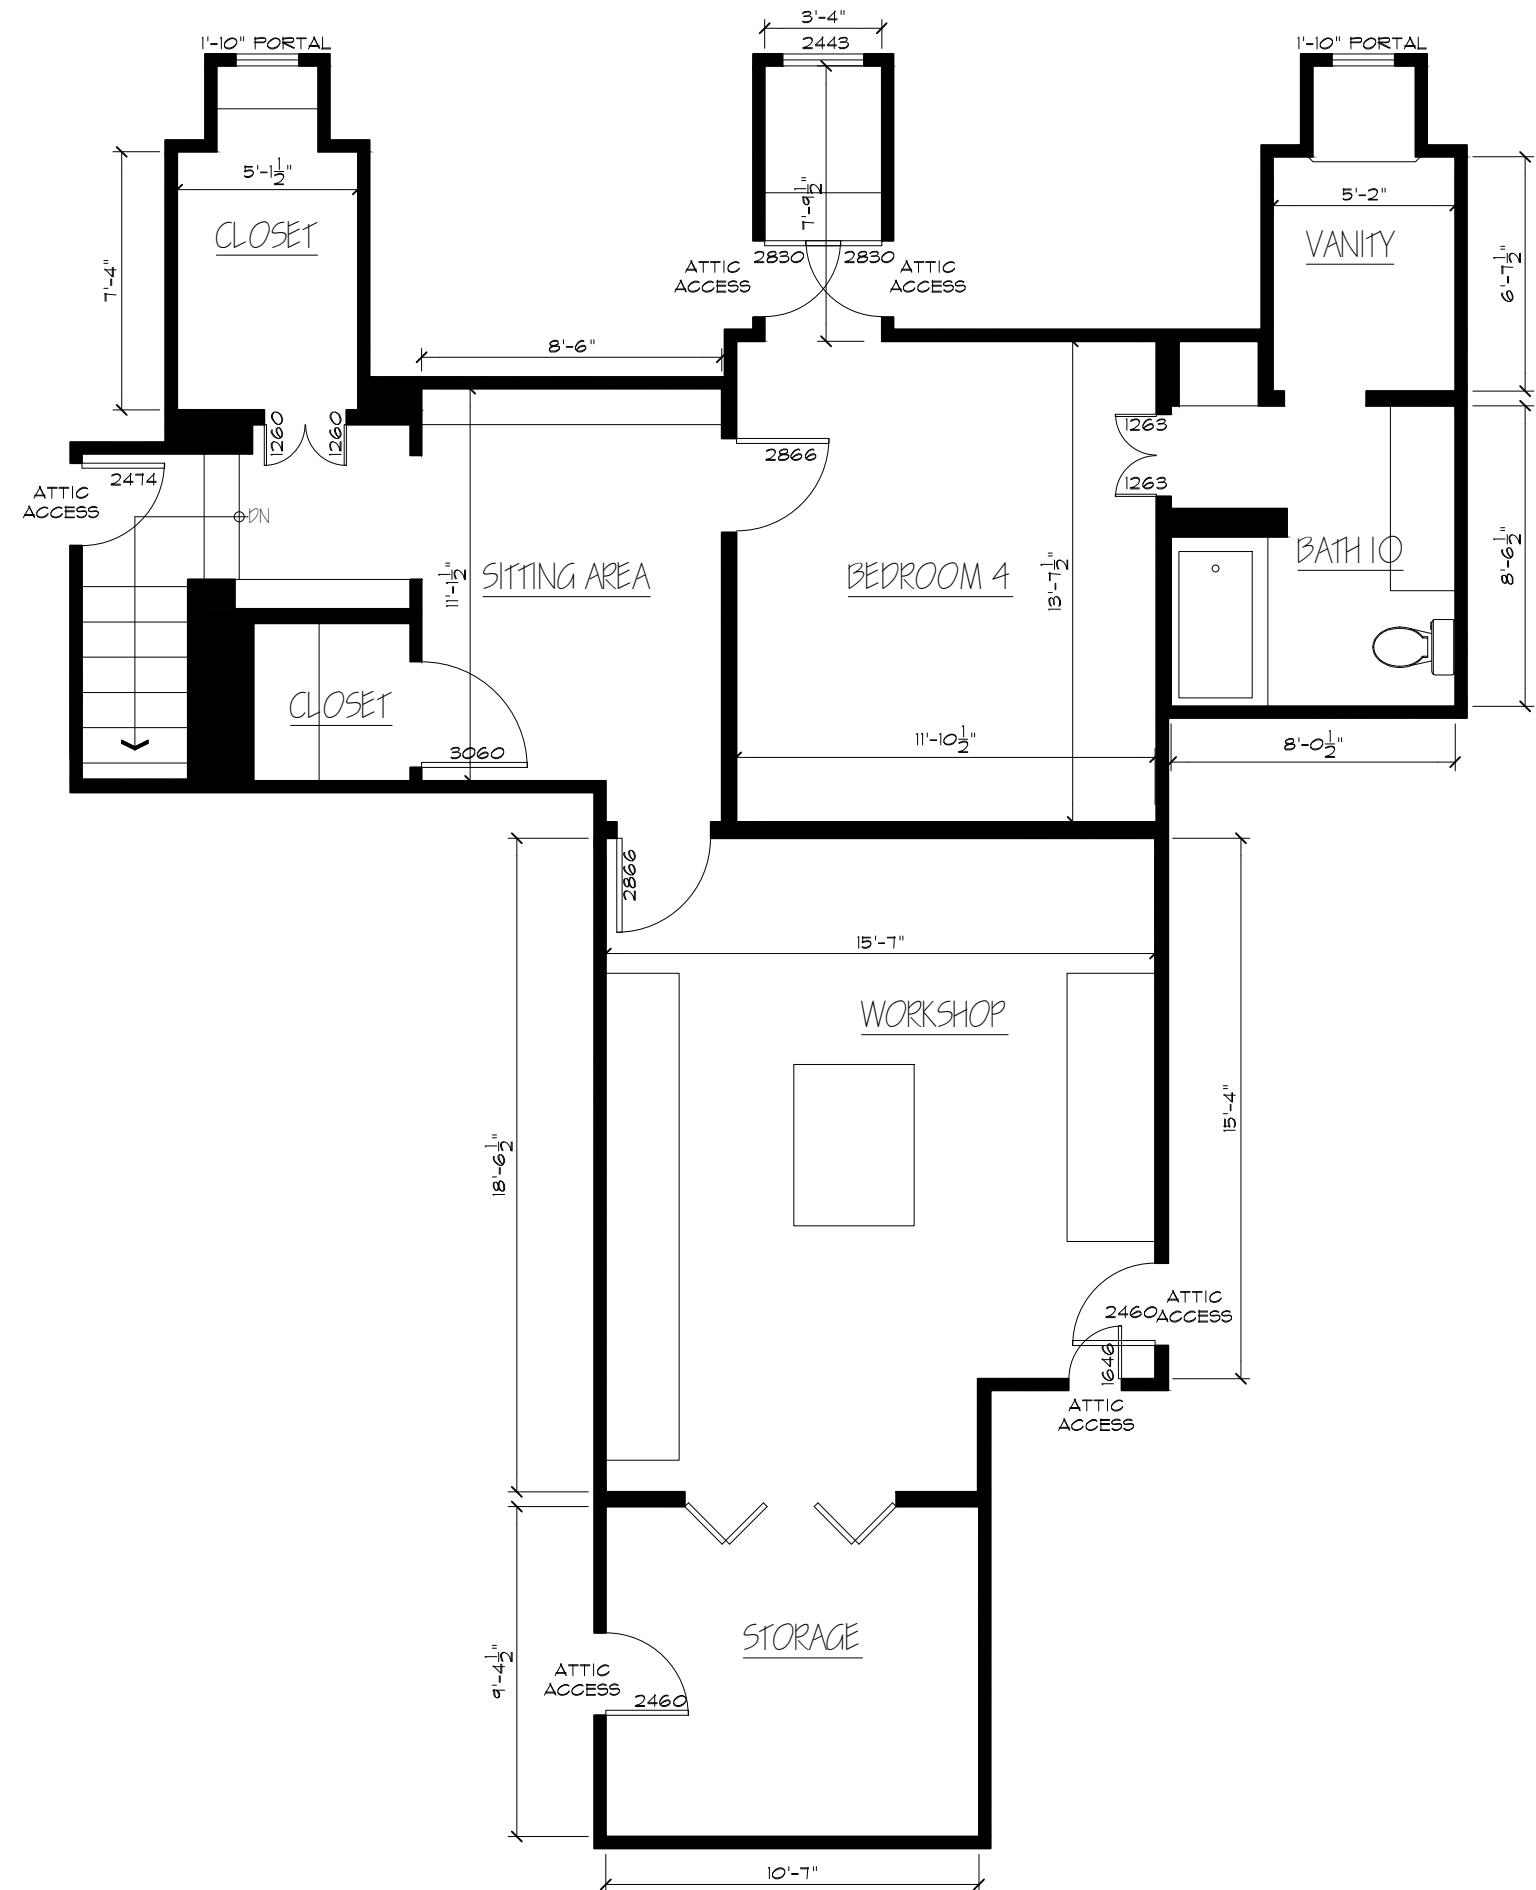


THIRD FLOOR PLAN



3RD FLOOR FINISH SCHEDULE				
ROOM NAME	FLOOR	WALLS	CEILING	NOTES
STORAGE ROOM	STAINED WOOD	PAINTED DRYWALL	PAINTED DRYWALL	
SITTING AREA	STAINED WOOD	PAINTED DRYWALL	PAINTED DRYWALL	
BEDROOM 4	STAINED WOOD	PAINTED DRYWALL	PAINTED DRYWALL	
BATH 10	TILE	PAINTED DRYWALL	PAINTED DRYWALL	
VANITY	TILE	PAINTED DRYWALL	PAINTED DRYWALL	
WORKSHOP	STAINED WOOD	PAINTED DRYWALL	PAINTED DRYWALL	

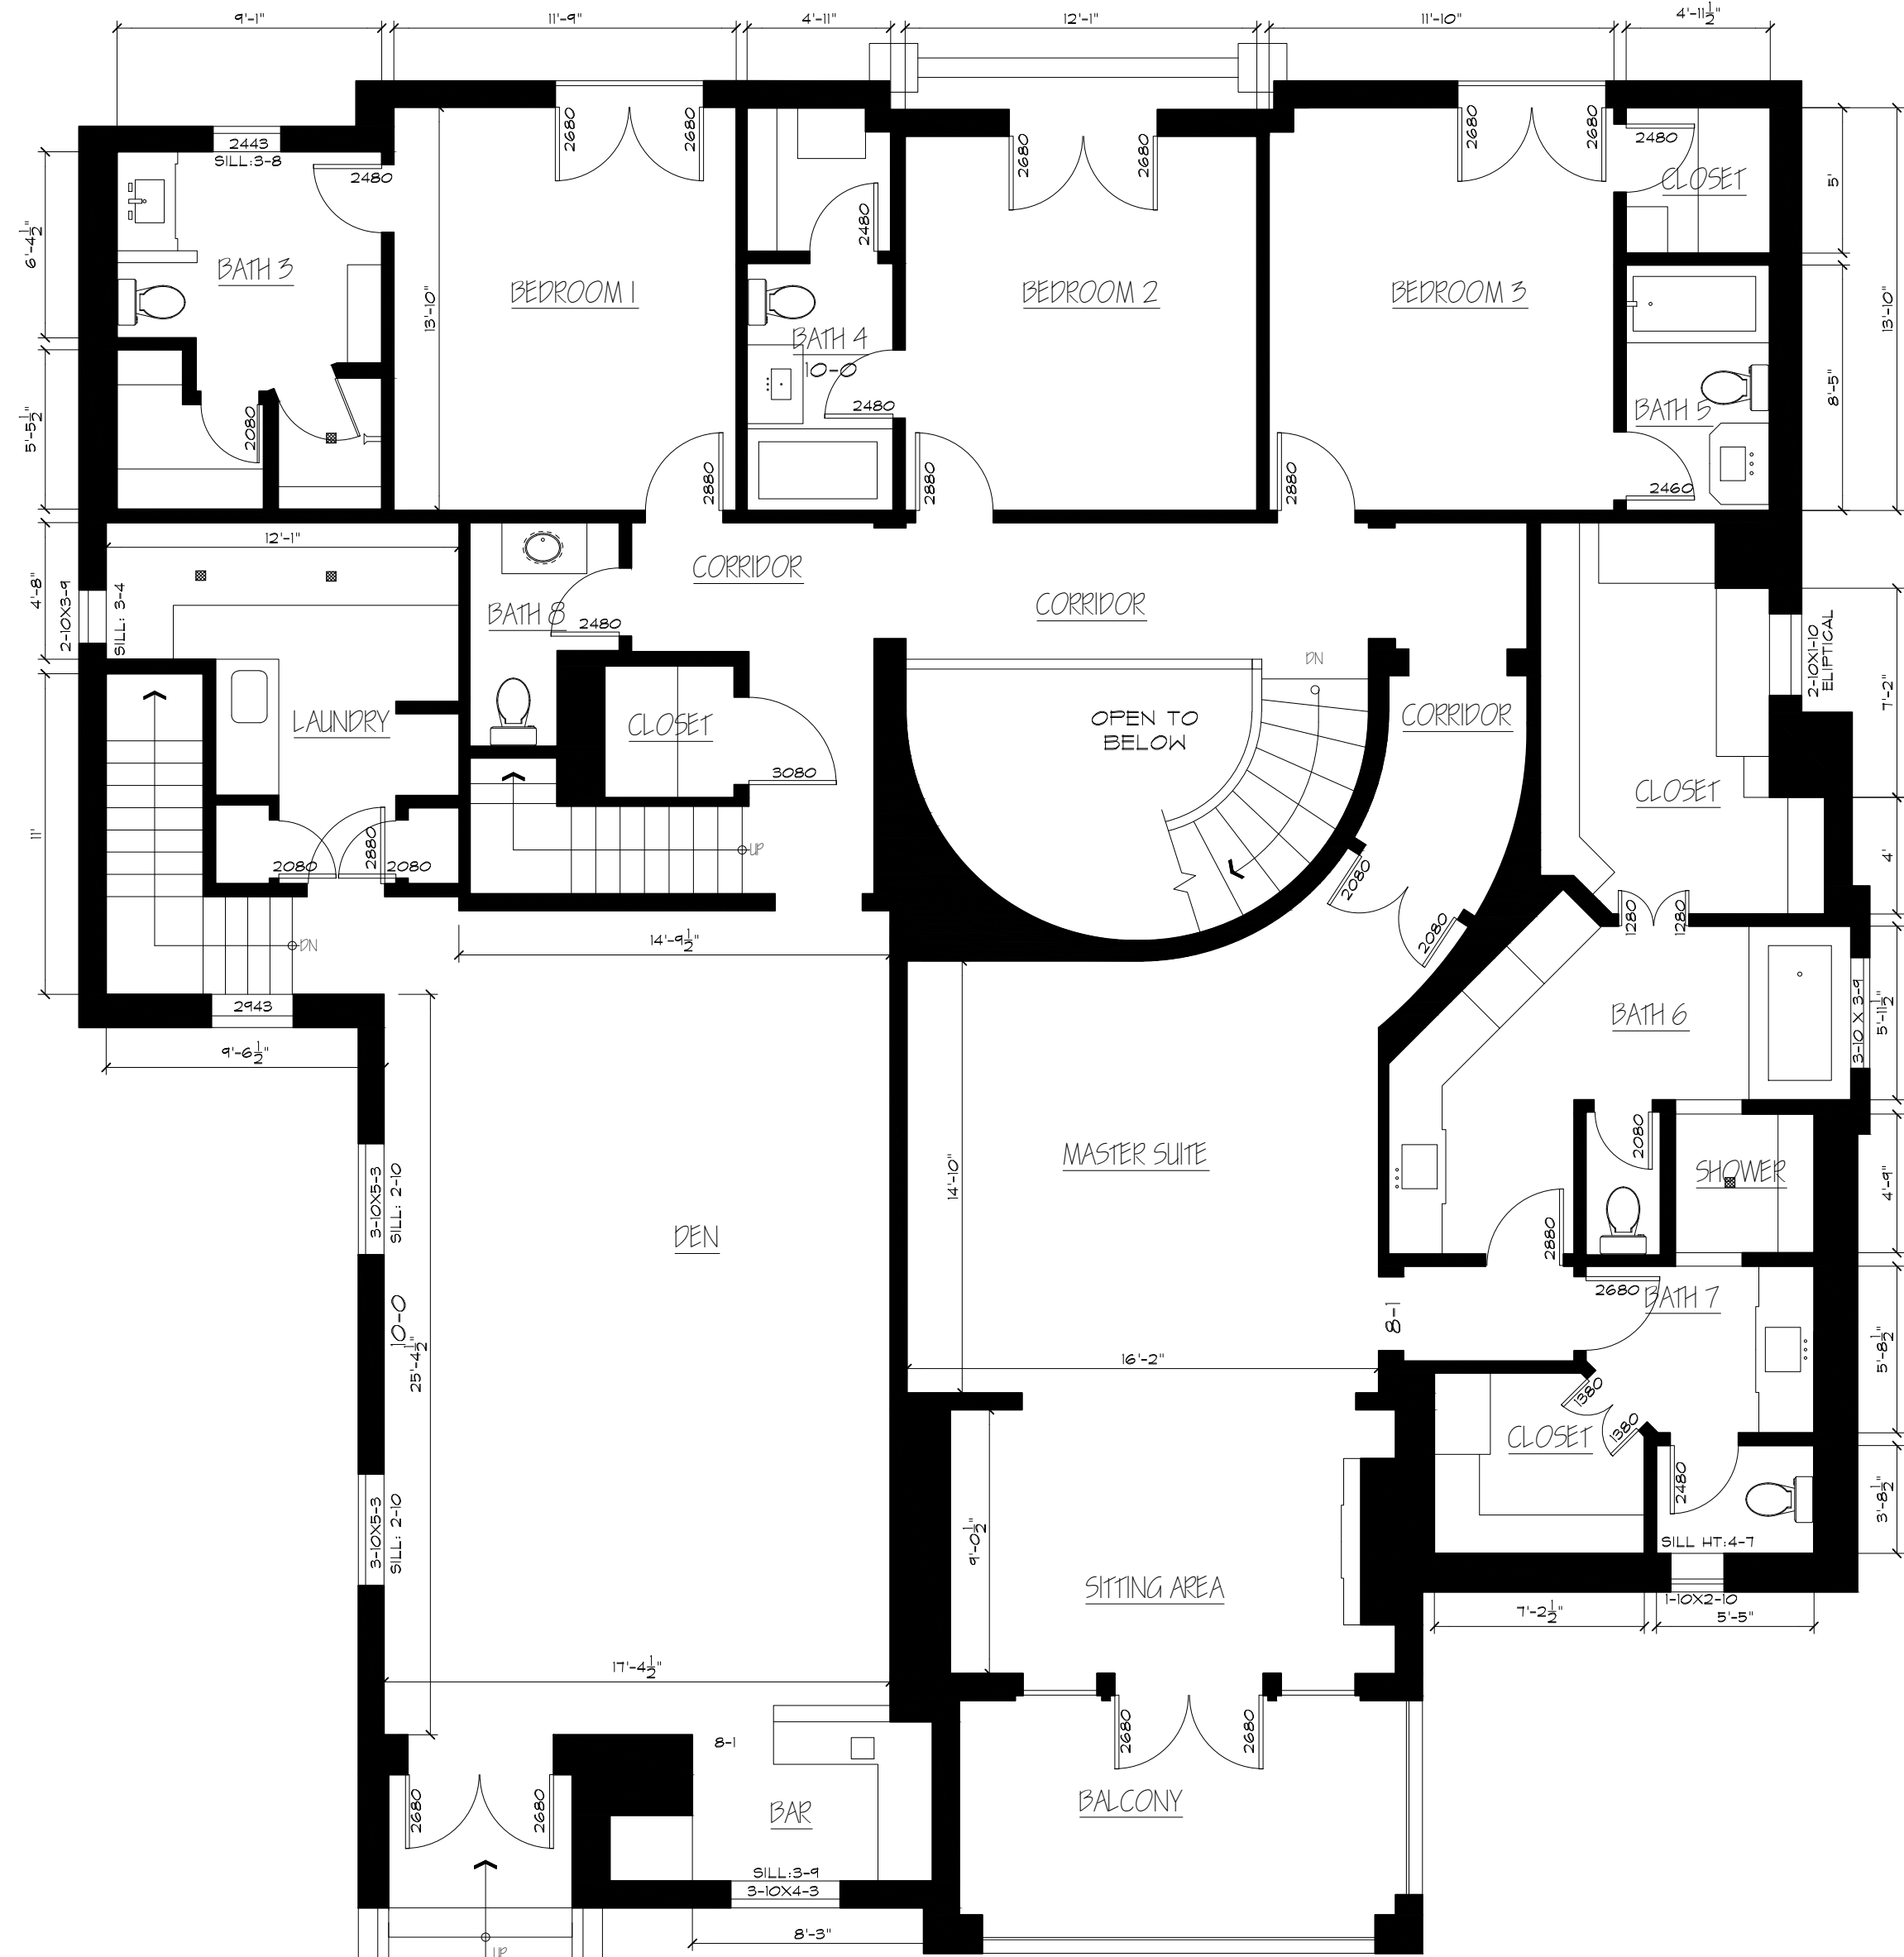

SECOND FLOOR PLAN

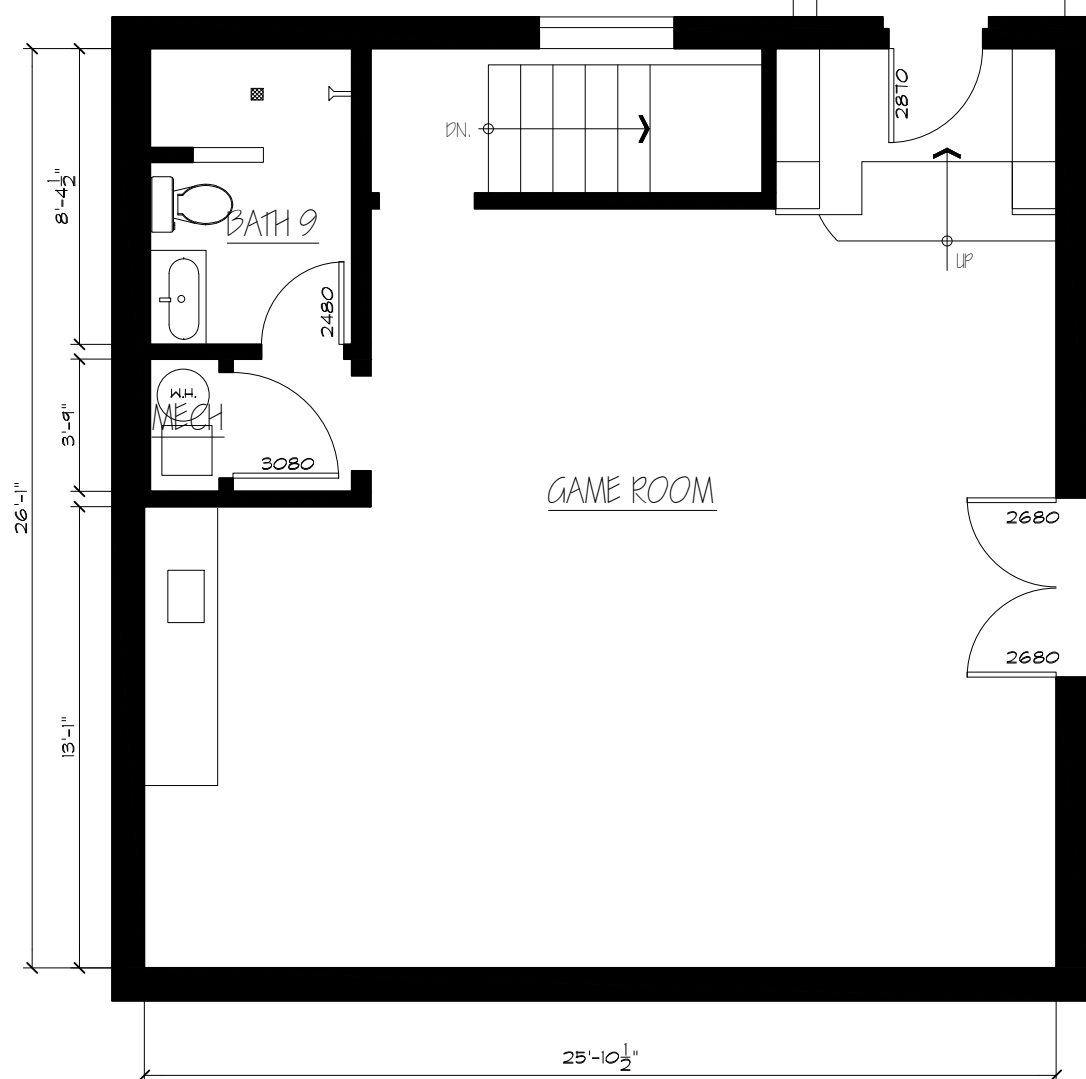


2ND FLOOR FINISH SCHEDULE				
ROOM NAME	FLOOR	WALLS	CEILING	NOTES
GAME ROOM	WOOD	PAINTED DRYWALL	PAINTED DRYWALL	
BATH 9	TILE	PAINTED CONCRETE	PAINTED METAL	TILE WAINSCOT UP TO 36"
DEN	STAINED WOOD	PAINTED DRYWALL	WOOD BEAMS	
LAUNDRY	STAINED WOOD	PAINTED DRYWALL	PAINTED DRYWALL	
BEDROOM 1	STAINED WOOD	PAINTED DRYWALL	PAINTED DRYWALL	
BATH 3	TILE	PAINTED DRYWALL	PAINTED DRYWALL	
BEDROOM 2	STAINED WOOD	PAINTED DRYWALL	PAINTED DRYWALL	
BATH 4	TILE	PAINTED DRYWALL	PAINTED DRYWALL	
BEDROOM 3	STAINED WOOD	PAINTED DRYWALL	PAINTED DRYWALL	
BATH 5	TILE	PAINTED DRYWALL	PAINTED DRYWALL	
MASTER SUITE	STAINED WOOD	PAINTED DRYWALL	PAINTED DRYWALL	
SITTING AREA	STAINED WOOD	PAINTED DRYWALL	PAINTED DRYWALL	
BATH 6	TILE	PAINTED DRYWALL	PAINTED DRYWALL	
BATH 7	TILE	WALL PAPER	WALL PAPER	
DINING ROOM	STAINED WOOD	PAINTED DRYWALL	PAINTED DRYWALL	WAINSCOT UP TO 36"
DESSERT ROOM	STAINED WOOD	PAINTED DRYWALL	PAINTED DRYWALL	
ENTRY	TILE	PAINTED DRYWALL	PAINTED DRYWALL	
LIVING ROOM	STAINED WOOD	PAINTED DRYWALL	PAINTED DRYWALL	
BATH 2	STAINED WOOD	PAINTED DRYWALL	PAINTED DRYWALL	TILE WAINSCOT UP TO 36"

SECOND AND
THIRD FLOOR
PLAN

HL	PROJECT MANAGER
HL	PROJECT DIRECTOR
012317-1	PROJECT NUMBER
3/16"=1'-0"	SCALE
MM	DRAWN BY
	SHEET NUMBER

LIGHT FIXTURE SCHEDULE						
QTY	TYPE	PHOTO	ROOM	MOUNT	# OF BULBS	NOTES
1	L1		PATIO	PENDANT EXTERIOR	3 EACH	
234	L2		ALL ROOMS	RECESSED CAN LIGHTING	1 EACH	6" DIA
2	L3		KITCHEN	PENDANT INTERIOR	3 EACH	
2	L4		PATIO	PENDANT EXTERIOR	3 EACH	
2	L5		GARAGE EXT.	WALL MOUNTED	3 EACH	
2	L6		VARIOUS	RECESSED LIGHTING	1 EACH	4" DIA
4	L7		GARAGE EXT.	WALL MOUNTED	2 EACH	
2	L8		CORR.	PENDANT INTERIOR	1 EACH	
14	L9		DEN	RECESSED LIGHTING	1 EACH	6" DIA
2	L10		BATH 8	WALL MOUNTED	1 EACH	
2	L11		BATH 3	WALL MOUNTED	1 EACH	
2	L12		BATH 4	WALL MOUNTED	1 EACH	
4	L13		GARAGE BASEMENT	CEILING FLORESCENT	2 EACH	3FT
	L14		VARIOUS	BARE BULB OR NO FIXTURE	1 EACH	

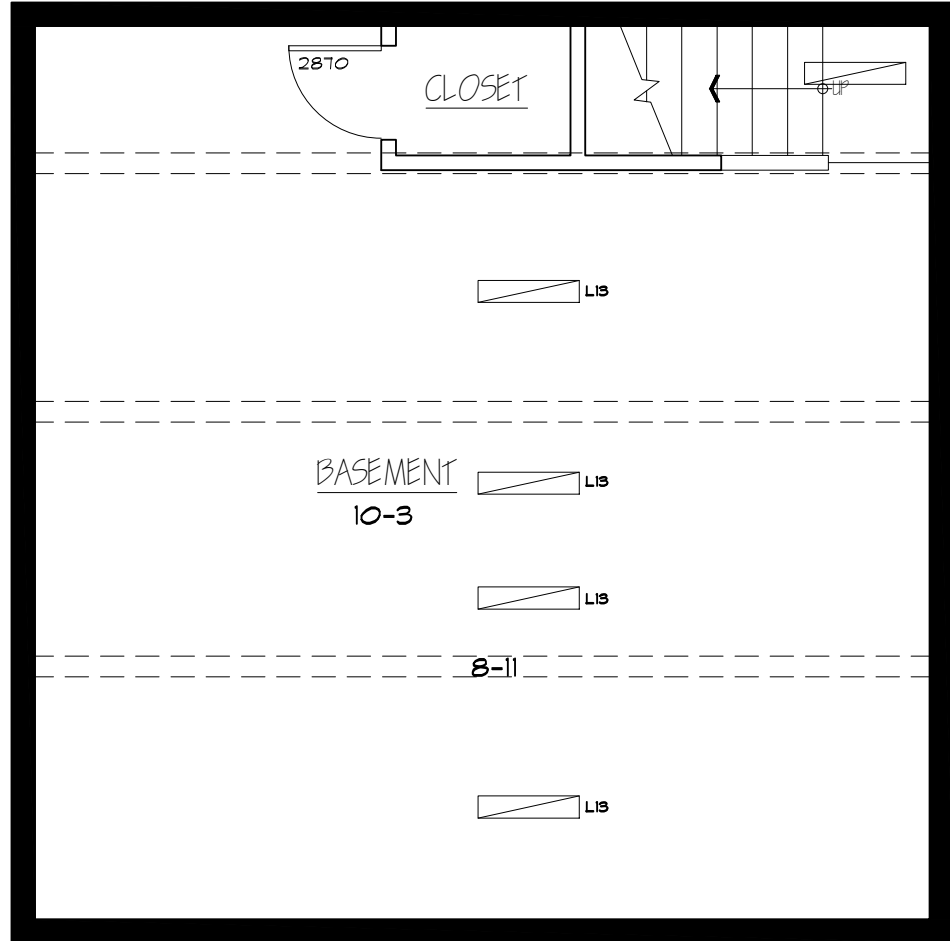

GARAGE BASEMENT




FIRST FLOOR PLAN



ARCHITECTURAL AS BUILT
HIGHLAND PARK RESIDENCE
DALLAS TX 75205


FIRST FLOOR &
BASEMENT
RCP

HL	PROJECT MANAGER
HL	PROJECT DIRECTOR
012317-1	PROJECT NUMBER
3/16"=1'-0"	SCALE
MM	DRAWN BY
	SHEET NUMBER

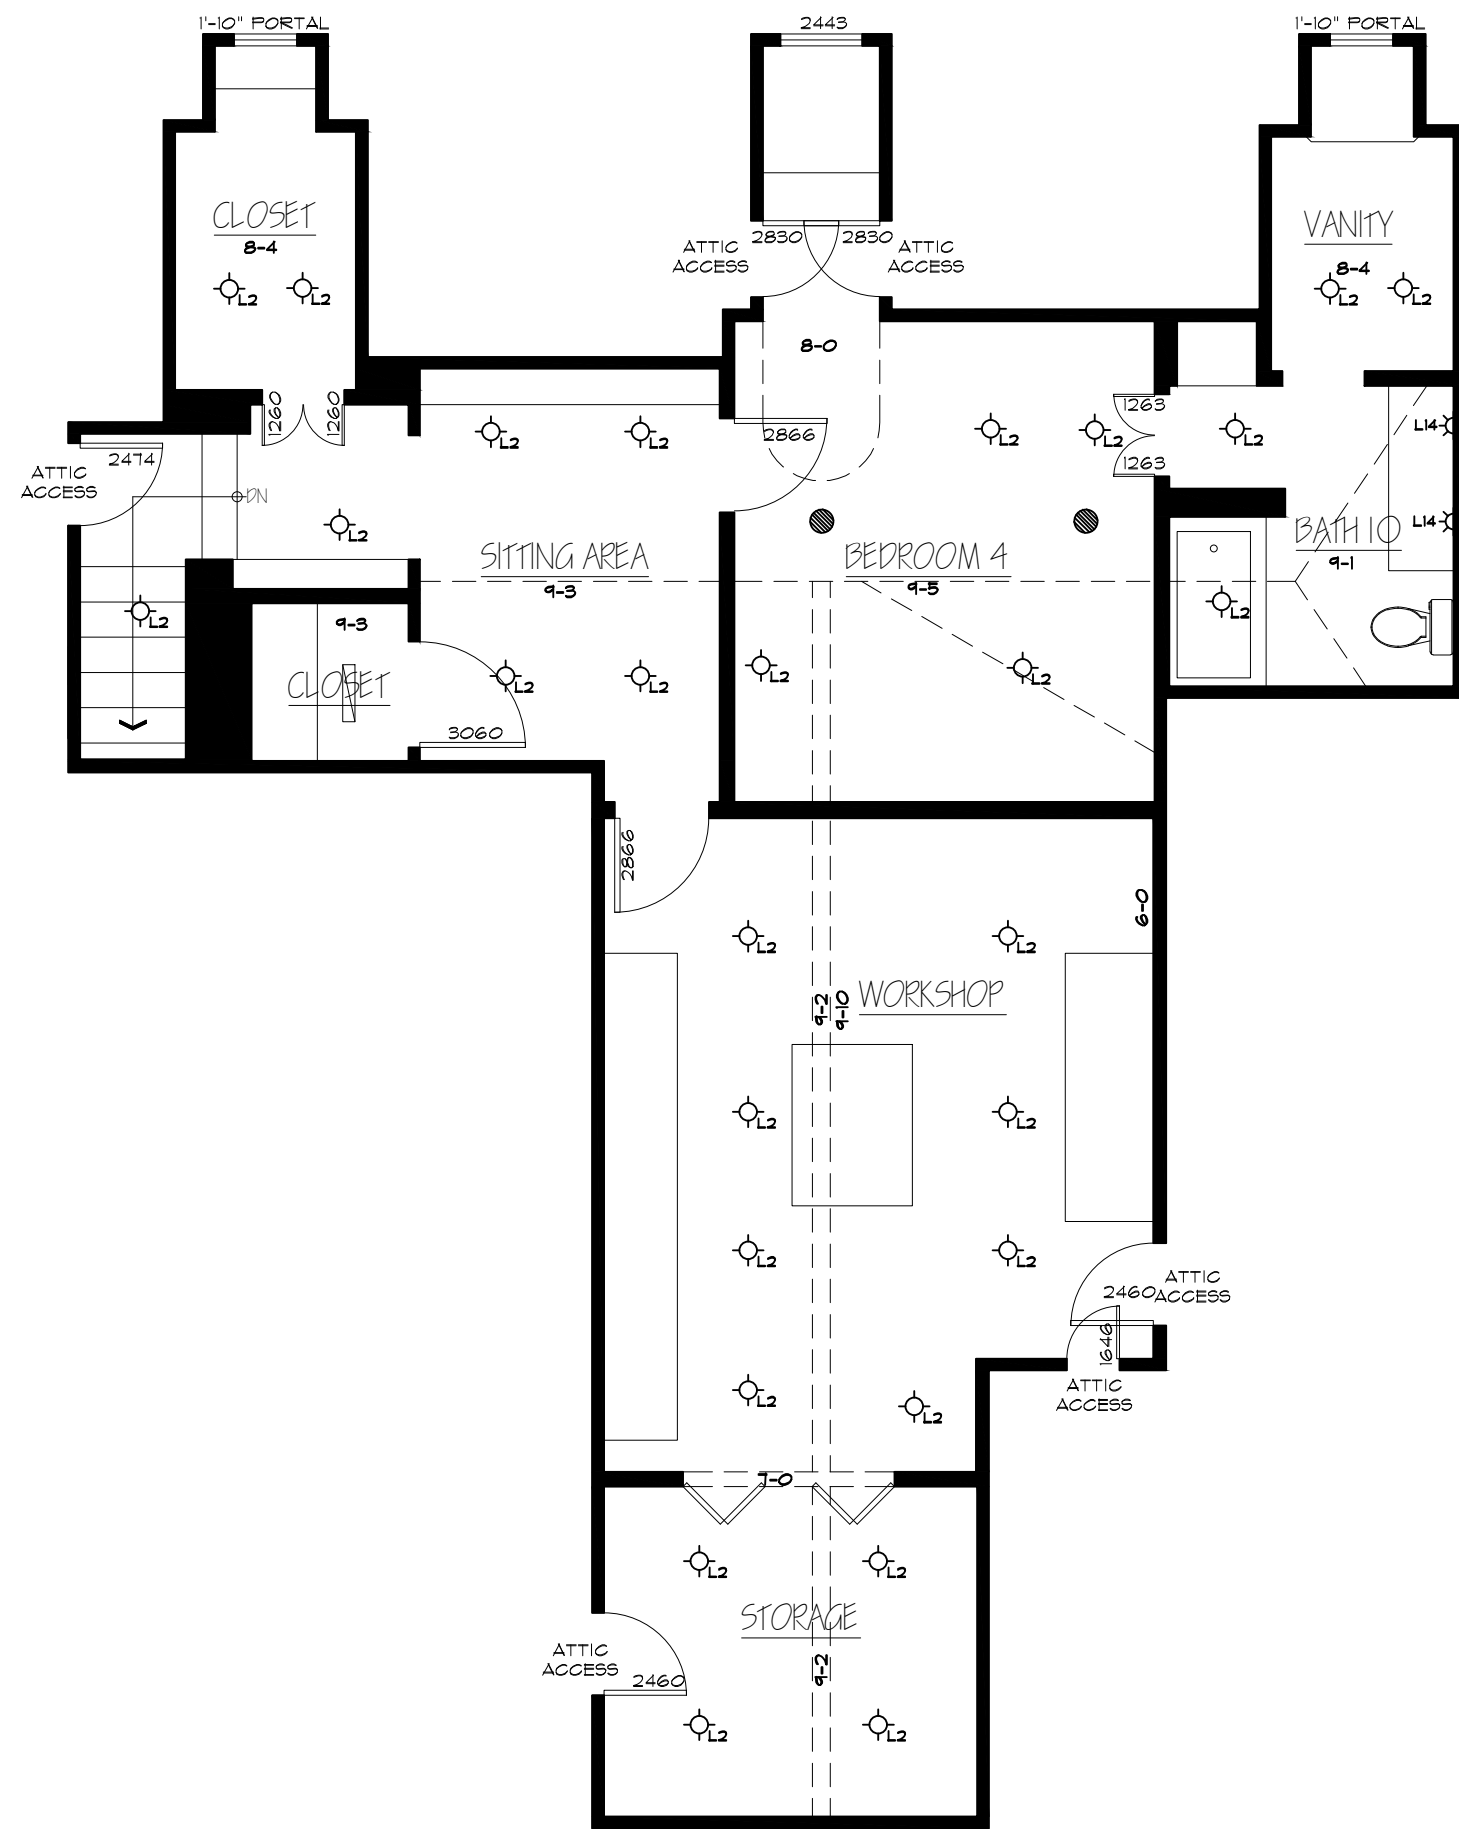


THIRD FLOOR PLAN

LIGHT FIXTURE SCHEDULE						
QTY	TYPE	PHOTO	ROOM	MOUNT	# OF BULBS	NOTES
1	L1		PATIO	PENDANT EXTERIOR	3 EACH	
234	L2		ALL ROOMS	RECESSED CAN LIGHTING	1 EACH	6" DIA
2	L3		KITCHEN	PENDANT INTERIOR	3 EACH	
2	L4		PATIO	PENDANT EXTERIOR	3 EACH	
2	L5		GARAGE EXT.	WALL MOUNTED	3 EACH	
2	L6		VARIOUS	RECESSED LIGHTING	1 EACH	4" DIA
4	L7		GARAGE EXT.	WALL MOUNTED	2 EACH	
2	L8		CORR.	PENDANT INTERIOR	1 EACH	
14	L9		DEN	RECESSED LIGHTING	1 EACH	6" DIA
2	L10		BATH 8	WALL MOUNTED	1 EACH	
2	L11		BATH 3	WALL MOUNTED	1 EACH	
2	L12		BATH 4	WALL MOUNTED	1 EACH	
4	L13		GARAGE BASEMENT	CEILING FLORESCENT	2 EACH	3FT
14	L14		VARIOUS	BARE BULB OR NO FIXTURE	1 EACH	

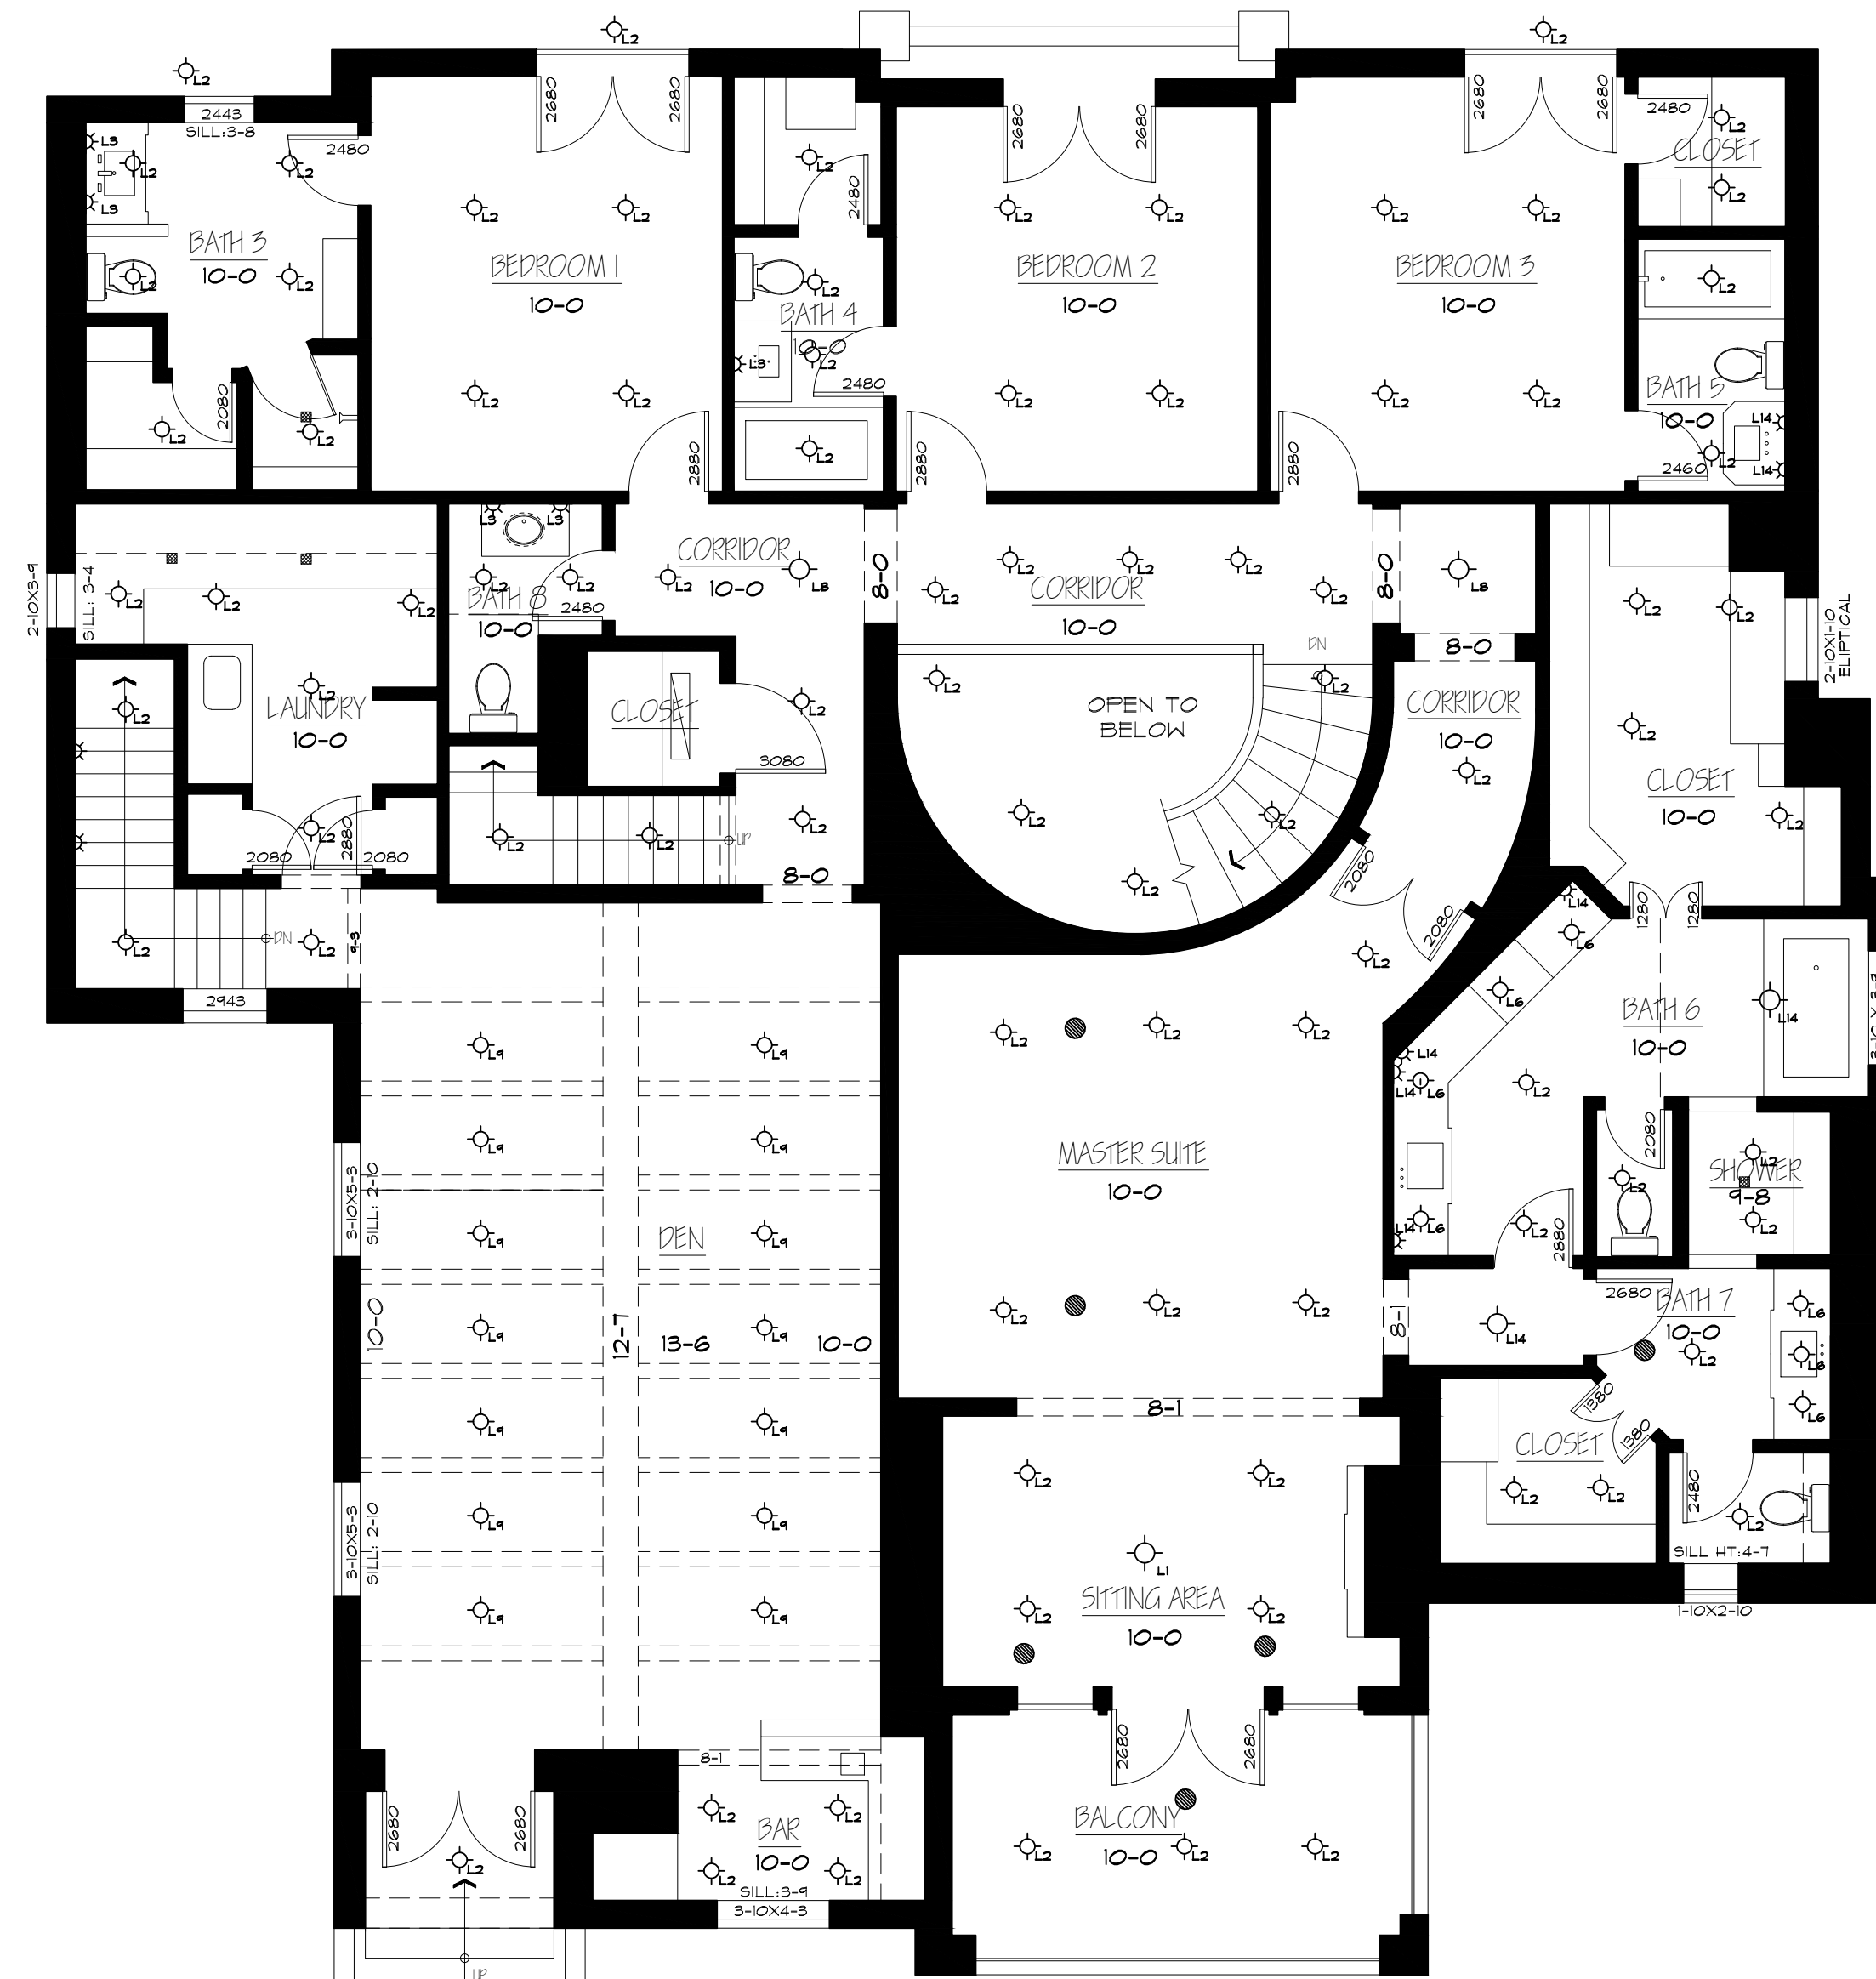

SECOND FLOOR PLAN

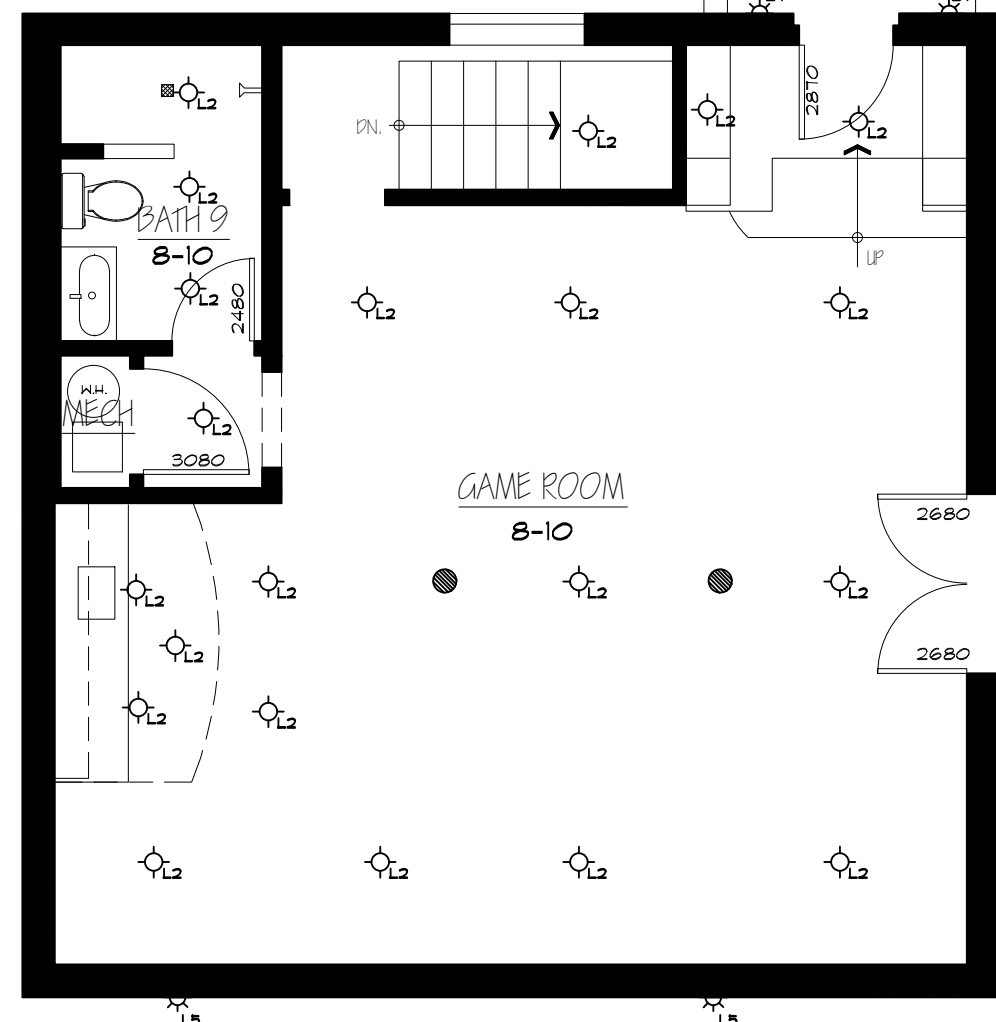


ARCHITECTURAL AS BUILT
HIGHLAND PARK RESIDENCE
DALLAS TX 75205

NO.	ISSUES REVISIONS	DATE
SHEET TITLE		
SECOND AND THIRD FLOOR RCP		
HL	PROJECT MANAGER	
HL	PROJECT DIRECTOR	
012317-1	PROJECT NUMBER	
3/16"=1'-0"	SCALE	
MM	DRAWN BY	
SHEET NUMBER		



 **ARCHITECTURAL AS BUILT
HIGHLAND PARK RESIDENCE**

[illegible]



This is a detailed architectural elevation drawing of a two-story building, likely a residential structure. The building is constructed from stone, with a central entrance featuring a double door under a semi-circular arch. To the left of the entrance is a large arched window, and to the right is a smaller arched window. Above the central entrance is a balcony with a decorative railing. The roof is gabled with a central dormer window. The drawing is a black and white line art, showing the intricate details of the stone masonry and architectural elements.



As BUILT
PROFESSIONALS
www.asbuiltprofessionals.com
 A DIVISION OF:



© 2020 AEC CONSULTANTS

**ARCHITECTURAL AS BUILT
HIGHLAND PARK RESIDENCE**



DALLAS TX 75205

[illegible]

EXTERIOR ELEVATIONS

HL	PROJECT MANAGER
HL	PROJECT DIRECTOR
012317-1	PROJECT NUMBER
1/4"=1'-0"	SCALE
MM	DRAWN BY
	SHEET NUMBER

AB-6

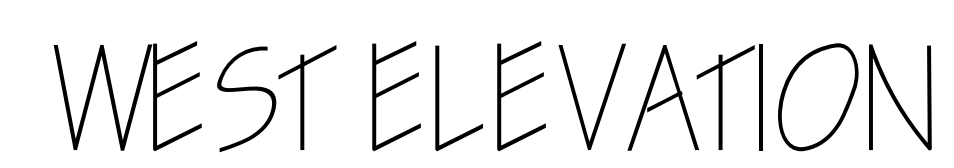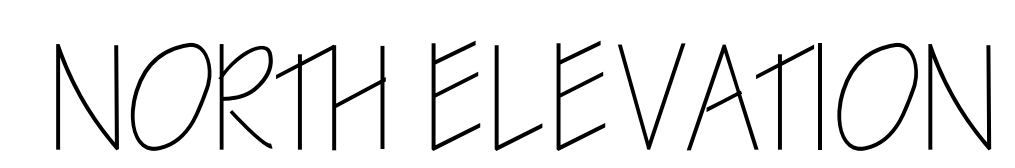

**ARCHITECTURAL AS BUILT
HIGHLAND PARK RESIDENCE**

DALLAS TX 75205

[illegible]