


AS-BUILT DOCUMENTATION

WEST HOLLYWOOD, CA 90069

DRAWING INDEX

- C-1 COVER SHEET | DRAWING INDEX
- SL SYMBOLS LEGEND
- AB-1 MAIN FLOOR & PARKING LEVEL PLAN
- AB-2 MAIN FLOOR & PARKING LEVEL RCP
- AB-3 MAIN FLOOR & PARKING LEVEL ELECTRICAL PLAN

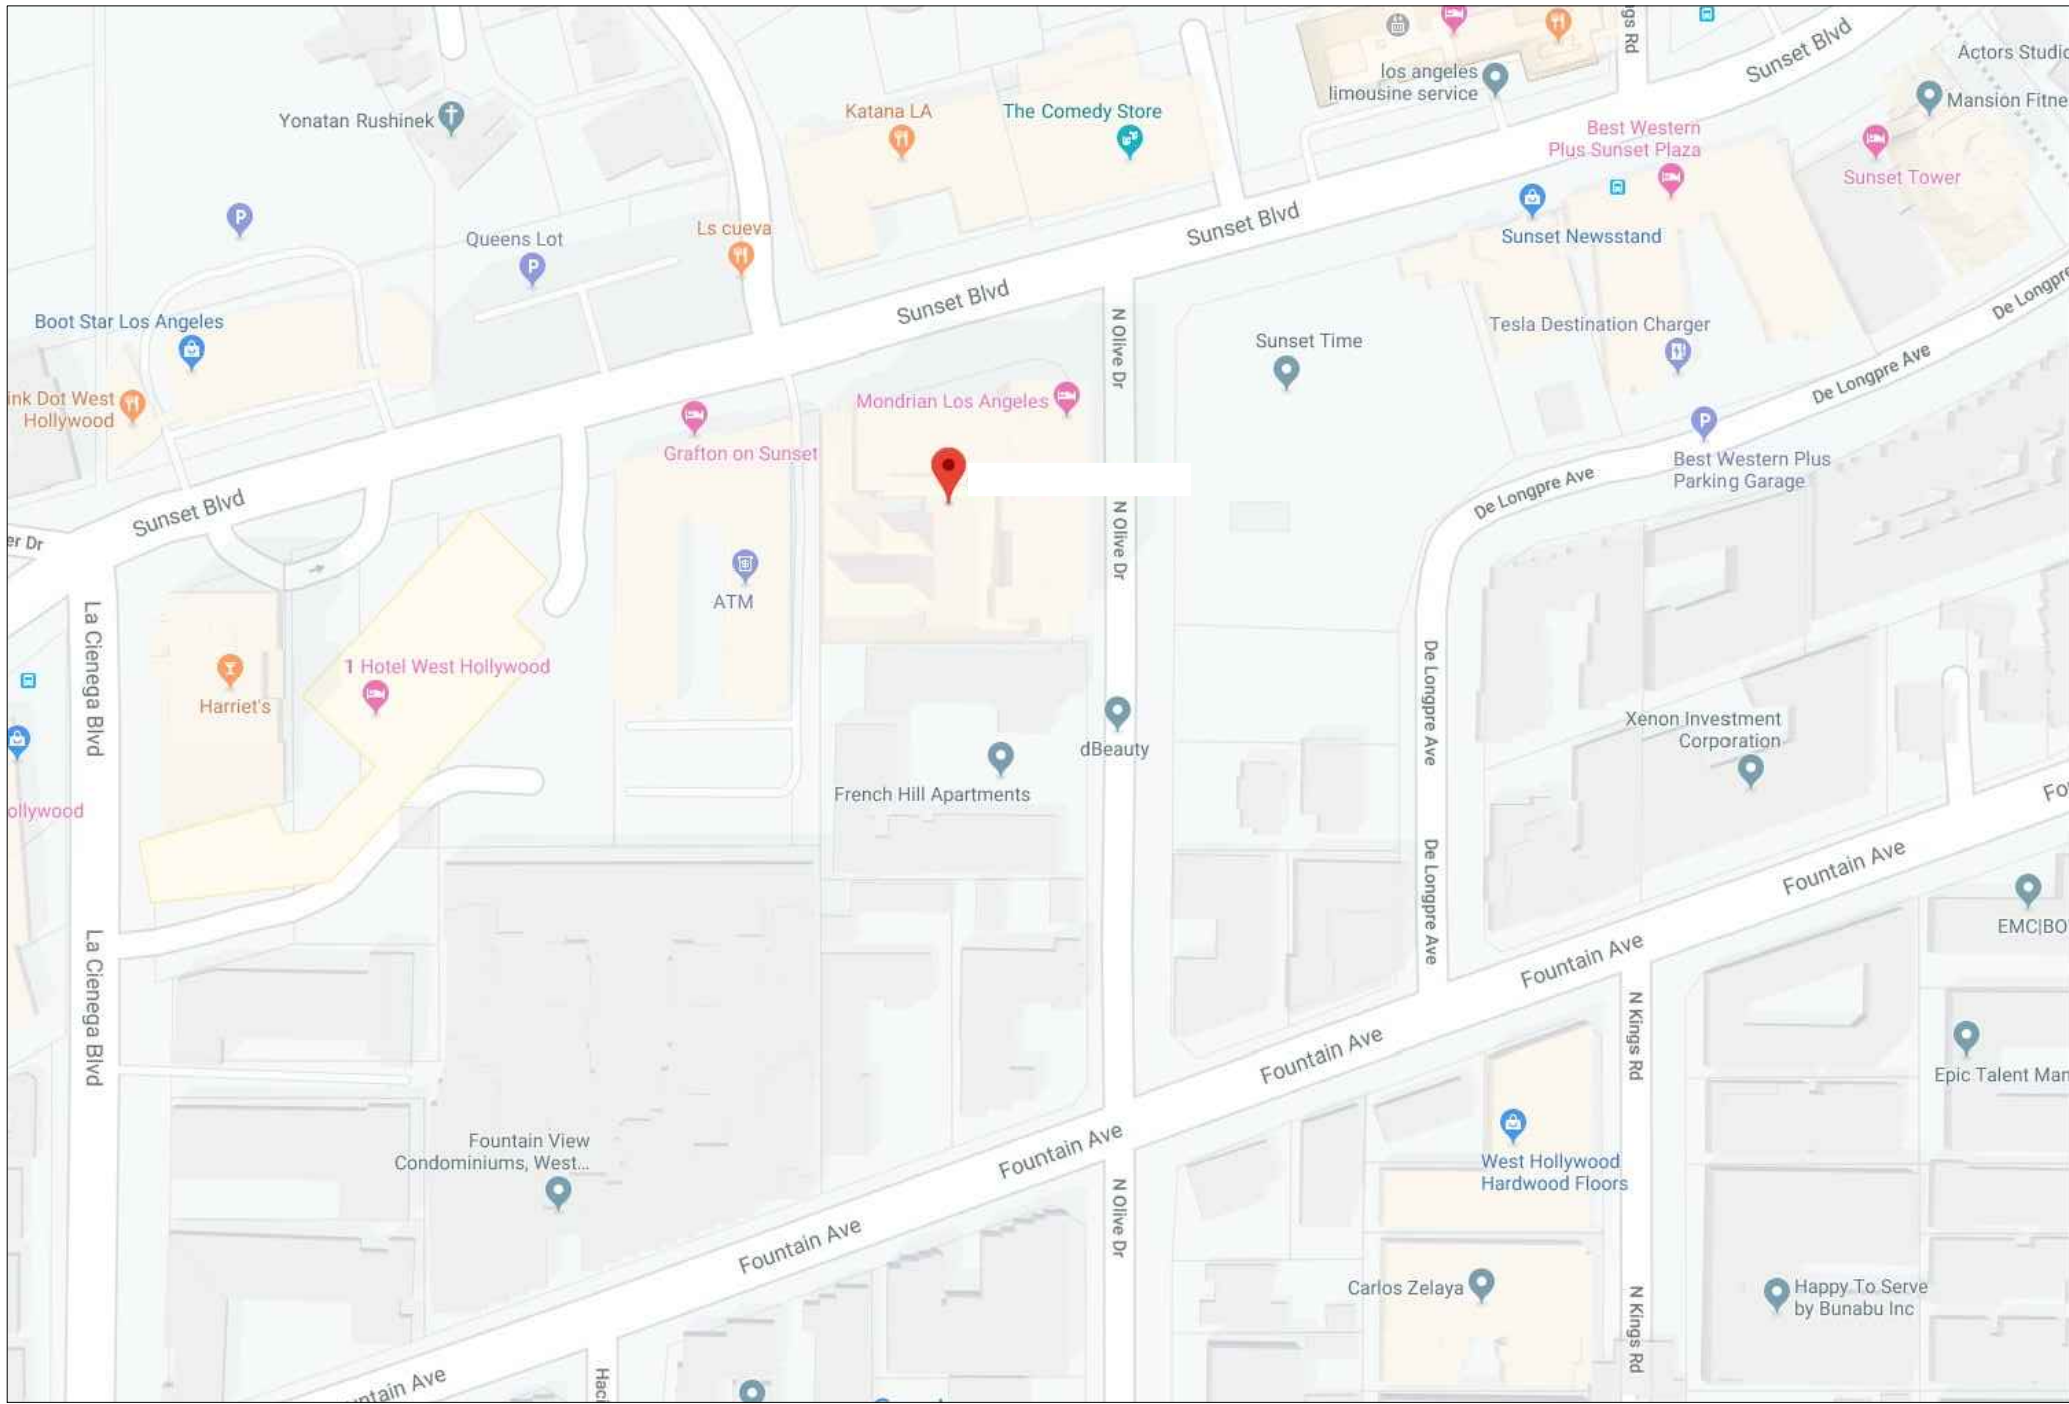

VICINITY MAP
NTS

GROSS AREA DATA	
MAIN FLOOR	14,236 S.F.
PARKING LEVEL	1,350 S.F.
GRAND TOTAL	15,586 S.F.

100% SUBMITTAL

ARCHITECTURAL AS BUILT
WEST HOLLYWOOD, CA 90069

COVER SHEET	
HL	PROJECT MANAGER
HL	PROJECT DIRECTOR
012317-1	PROJECT NUMBER
	SCALE
CL	DRAWN BY
C-1	
SHEET NUMBER	

SYMBOLS LEGEND

RCP

	EXHAUST VENT		TRACK LIGHT OR VANITY LIGHT
	CEILING MOUNTED LIGHT FIXTURE		WALL-MOUNTED LIGHT FIXTURE
	CEILING MOUNTED DIRECTIONAL LIGHT		EMERGENCY EXIT SIGN
	RECESSED CAN LIGHT		EMERGENCY EXIT LIGHT
	EYEBALL OR SMALL CAN LIGHT		EMERGENCY EXIT LIGHT W/ SIGN
	PENDANT LIGHT		LIGHTED STAIR SIGN
	INDIVIDUAL FLUOR. LAY-IN FIXTURE 4 BULB		FLOOD LIGHT
	INDIVIDUAL FLUOR. HANGING FIXTURE 2 BULB		PHOTO CELL
	INDIVIDUAL FLUOR. FLUSH MOUNT FIXTURE 4 BULB		CEILING FAN
	CAMERA		CEILING FAN W/ LIGHT KIT
	MOTION DET.		7-2-6 CEILING HEIGHT AND TRIM 7'-2" ABOVE FLOOR BELOW WITH 6" CROWN MOULDING. NOTE: ALL CEILINGS NOT LABELED ARE PLASTER. CEILINGS SHOWN WITH A GRID ARE LAY IN ACOUSTICAL TILE..
	SUPPLY VENT		JUNCTION BOX
	SUPPLY VENT		
	RETURN VENT		
	RETURN VENT		
	SPEAKER		

ELECTRIC

	DATA OUTLET
	TELEPHONE JACK
	ELECTRIC SWITCH
	CABLE TELEVISION OUTLET
	DUPLEX RECEPTACLE OUTLET
	SPECIAL PURPOSE CONNECTION OR OUTLET
	QUADRUPLUX RECEPTACLE OUTLET
	FLOOR DUPLEX RECEPTACLE OUTLET
	ELECTRIC PANEL
	ELECTRIC METER
	BUTTON SWITCH
	DISCONNECT SWITCH
	GROUND/FLOOR LIGHT
	KEY PAD

FIRE PROTECTION


	FIRE EXTINGUISHER
	FIRE PULL
	FIRE ALARM (HORN/SRTOBE)
	SMOKE DETECTOR
	SMOKE ALARM SPEAKER
	SPRINKLER HEAD CEILING MOUNT
	SPRINKLER HEAD WALL MOUNT

MEP


	THERMOSTAT
	FLOOR DRAIN
	VALVE
	HOSE BIB
	WATER SUPPLY
	SUSPENDED GAS HEATER

MISC

	BOLLARD
	SPOT ELEVATION

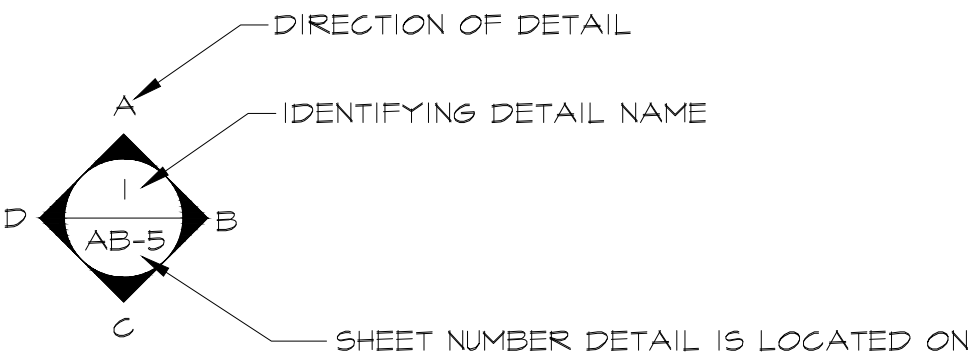

INTERIOR ELEVATIONS

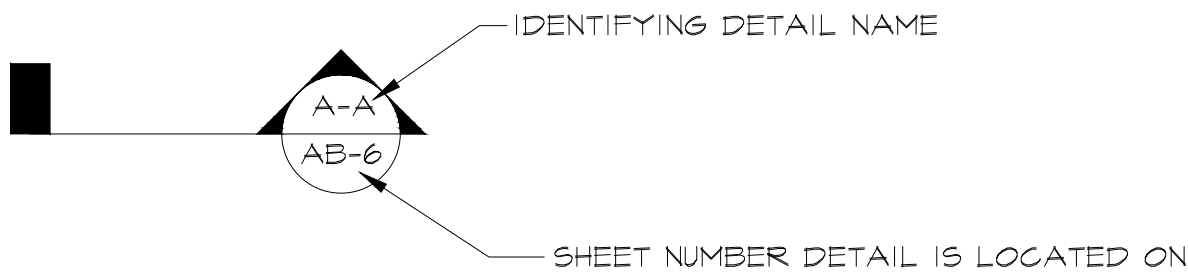

BUILDING SECTION

PHOTO DOCUMENTATION LEGEND

INDICATES LOCATION OF CAMERA


INDICATES DIRECTION OF CAMERA LENS AND CORRESPONDING PHOTO / VIDEO NUMBER

TYPES OF DOCUMENTATION

	GROUND BASED PHOTO		GROUND BASED VIDEO		360° SPHERICAL PHOTO		AERIAL BASED PHOTO		AERIAL BASED VIDEO
--	--------------------	--	--------------------	--	----------------------	--	--------------------	--	--------------------

ARCHITECTURAL AS BUILT
WEST HOLLYWOOD, CA 90069

01	100% SUBMISSION	SEE COVER SHEET
NO.	ISSUES REVISIONS	DATE
		SHEET TITLE
HL		PROJECT MANAGER
HL		PROJECT DIRECTOR
012317-1		PROJECT NUMBER
NOT TO SCALE		SCALE
CL		DRAWN BY
		SHEET NUMBER

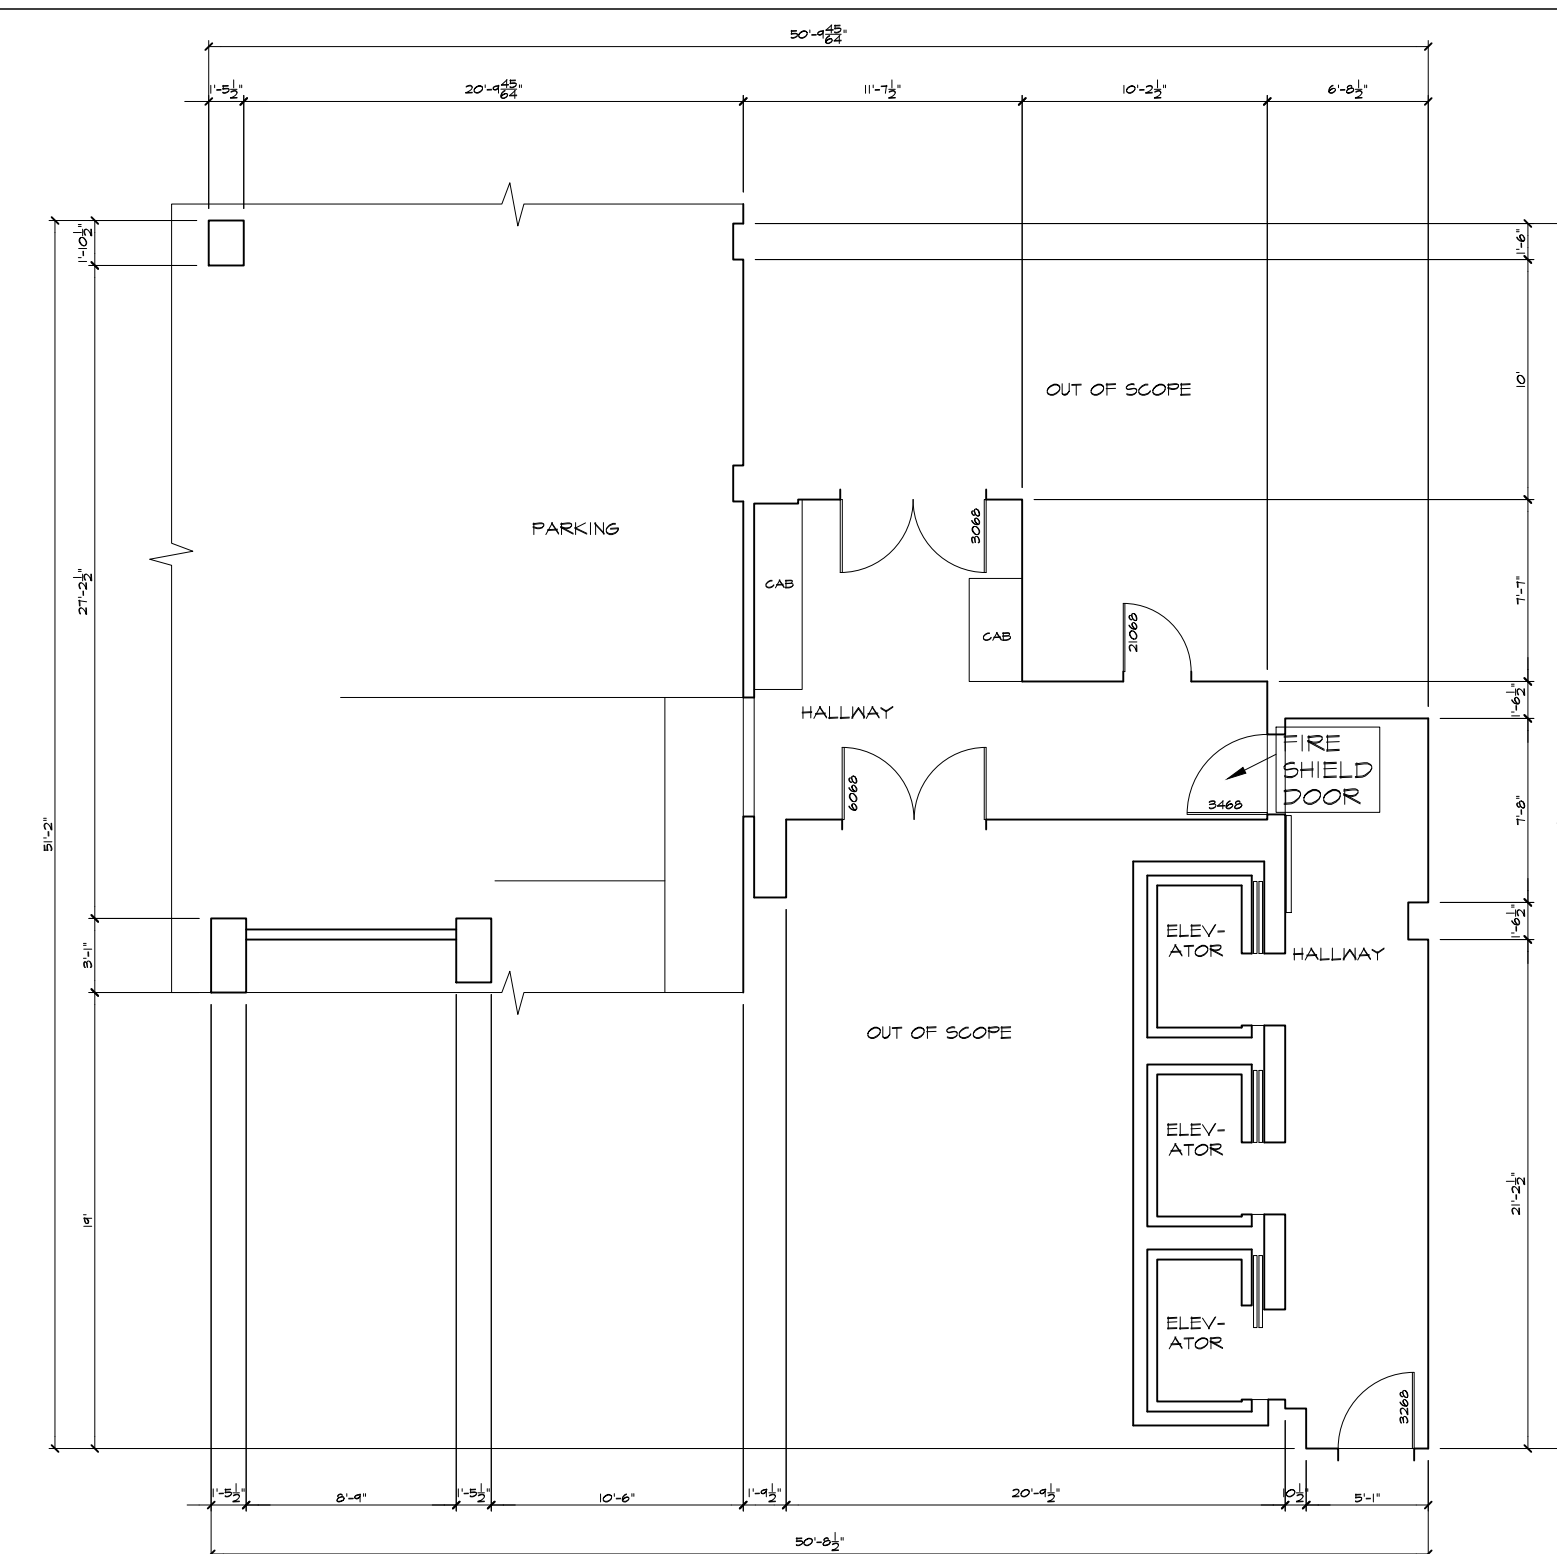

MAIN FLOOR 1/8"=1'-0"




ARCHITECTURAL AS BUILT

WEST HOLLYWOOD, CA 90069


01	100% SUBMISSION	SEE COVER SHEET
NO.	ISSUES REVISIONS	DATE
SHEET TITLE		
MAIN FLOOR & PARKING LEVEL PLAN		
HL	PROJECT MANAGER	
HL	PROJECT DIRECTOR	
012317-1	PROJECT NUMBER	
1/8"=1'-0"	SCALE	
CL	DRAWN BY	
SHEET NUMBER		

MAIN FLOOR & PARKING LEVEL PLAN

AB-1

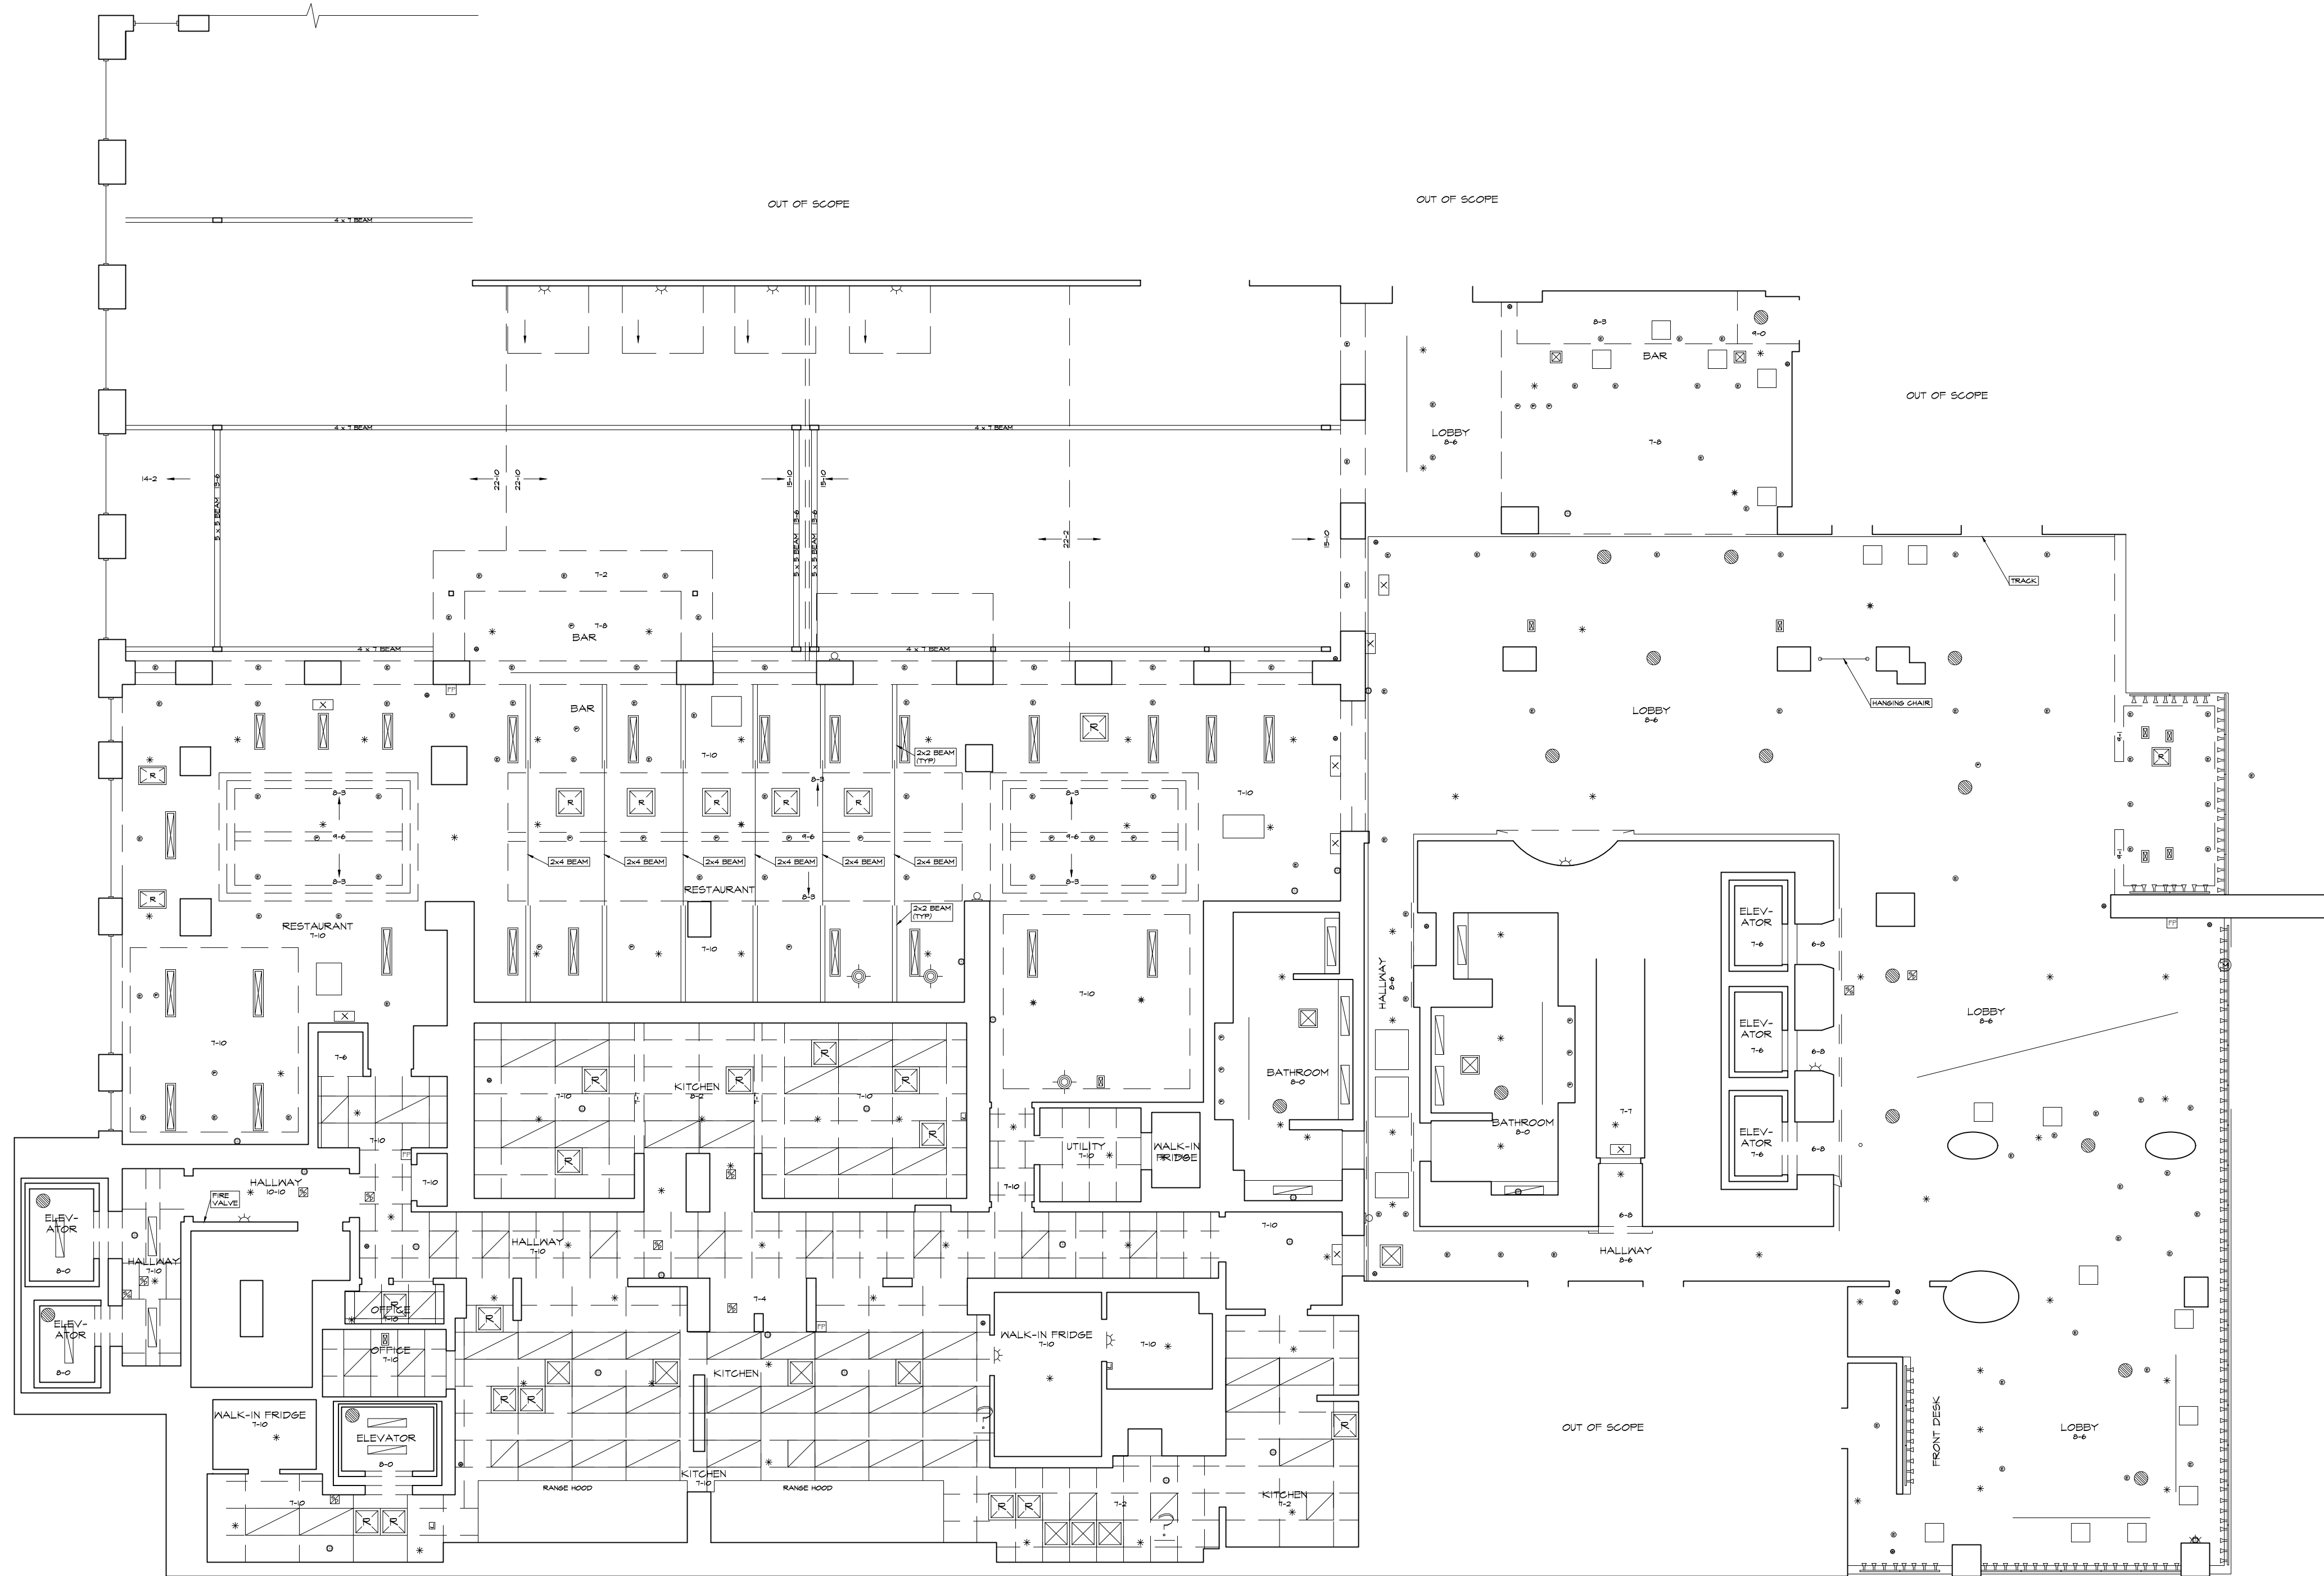

MAIN FLOOR 1/8"=1'-0"

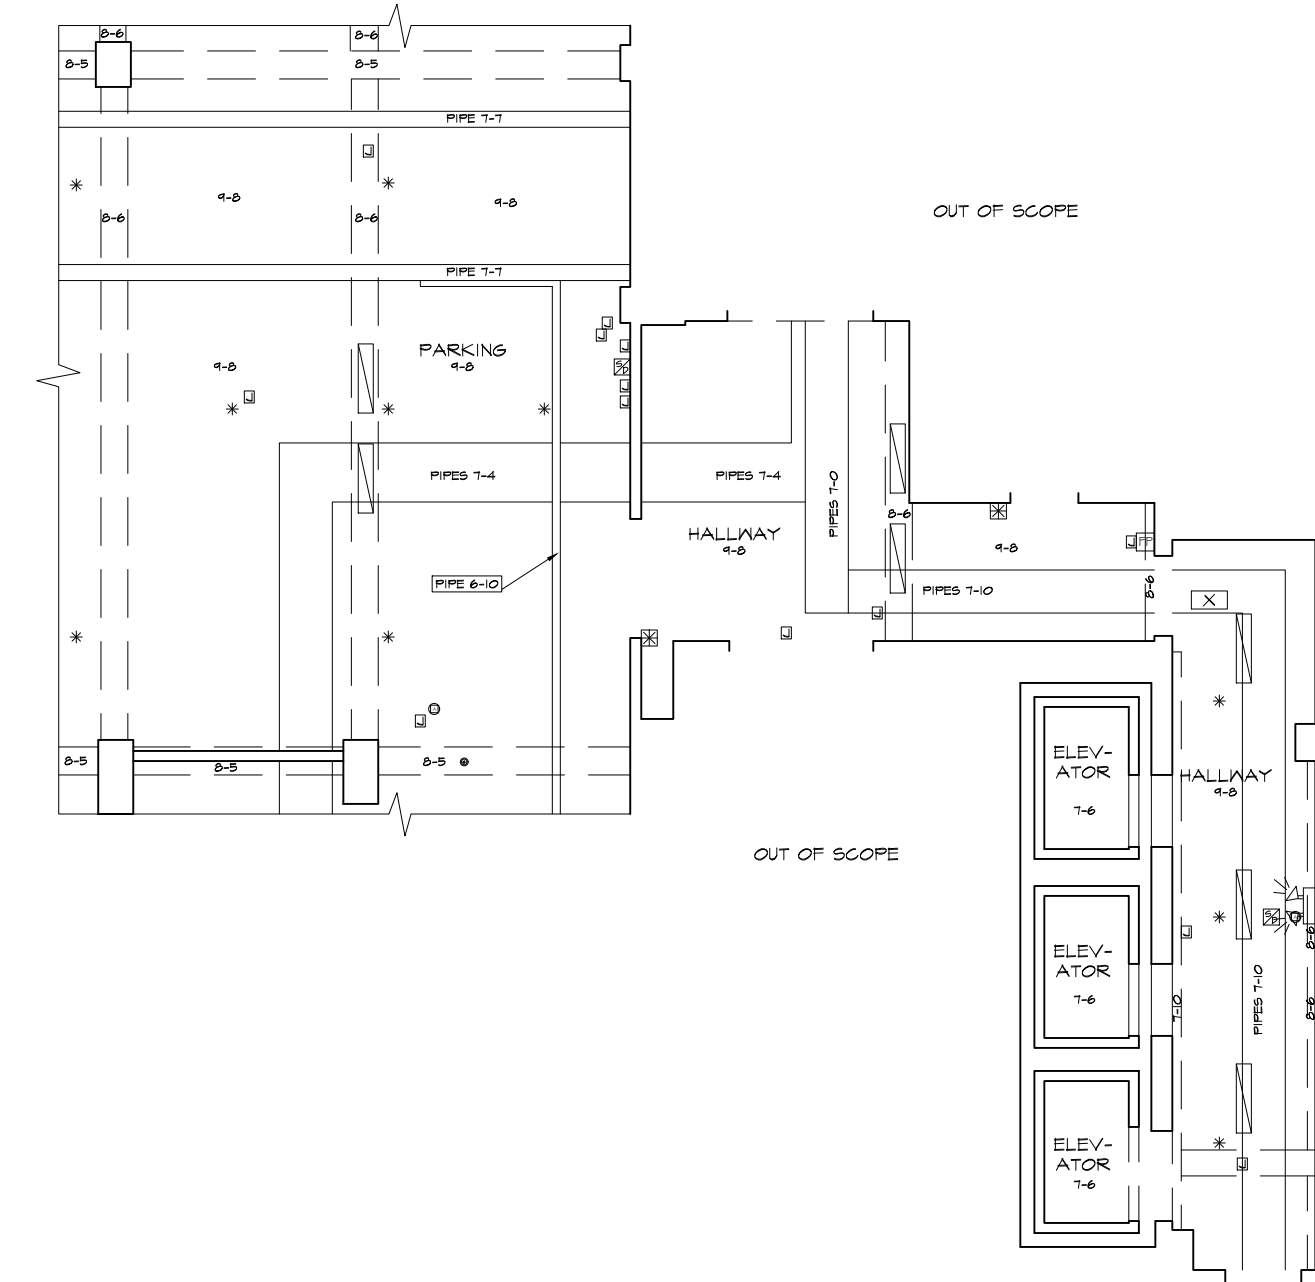


PARKING LEVEL 1/8"=1'-0"


ARCHITECTURAL AS BUILT
WEST HOLLYWOOD, CA 90069

**MAIN FLOOR &
PARKING LEVEL
RCP**

HL	PROJECT MANAGER
HL	PROJECT DIRECTOR
012317-1	PROJECT NUMBER
1/8"=1'-0"	SCALE
CL	DRAWN BY
	SHEET NUMBER

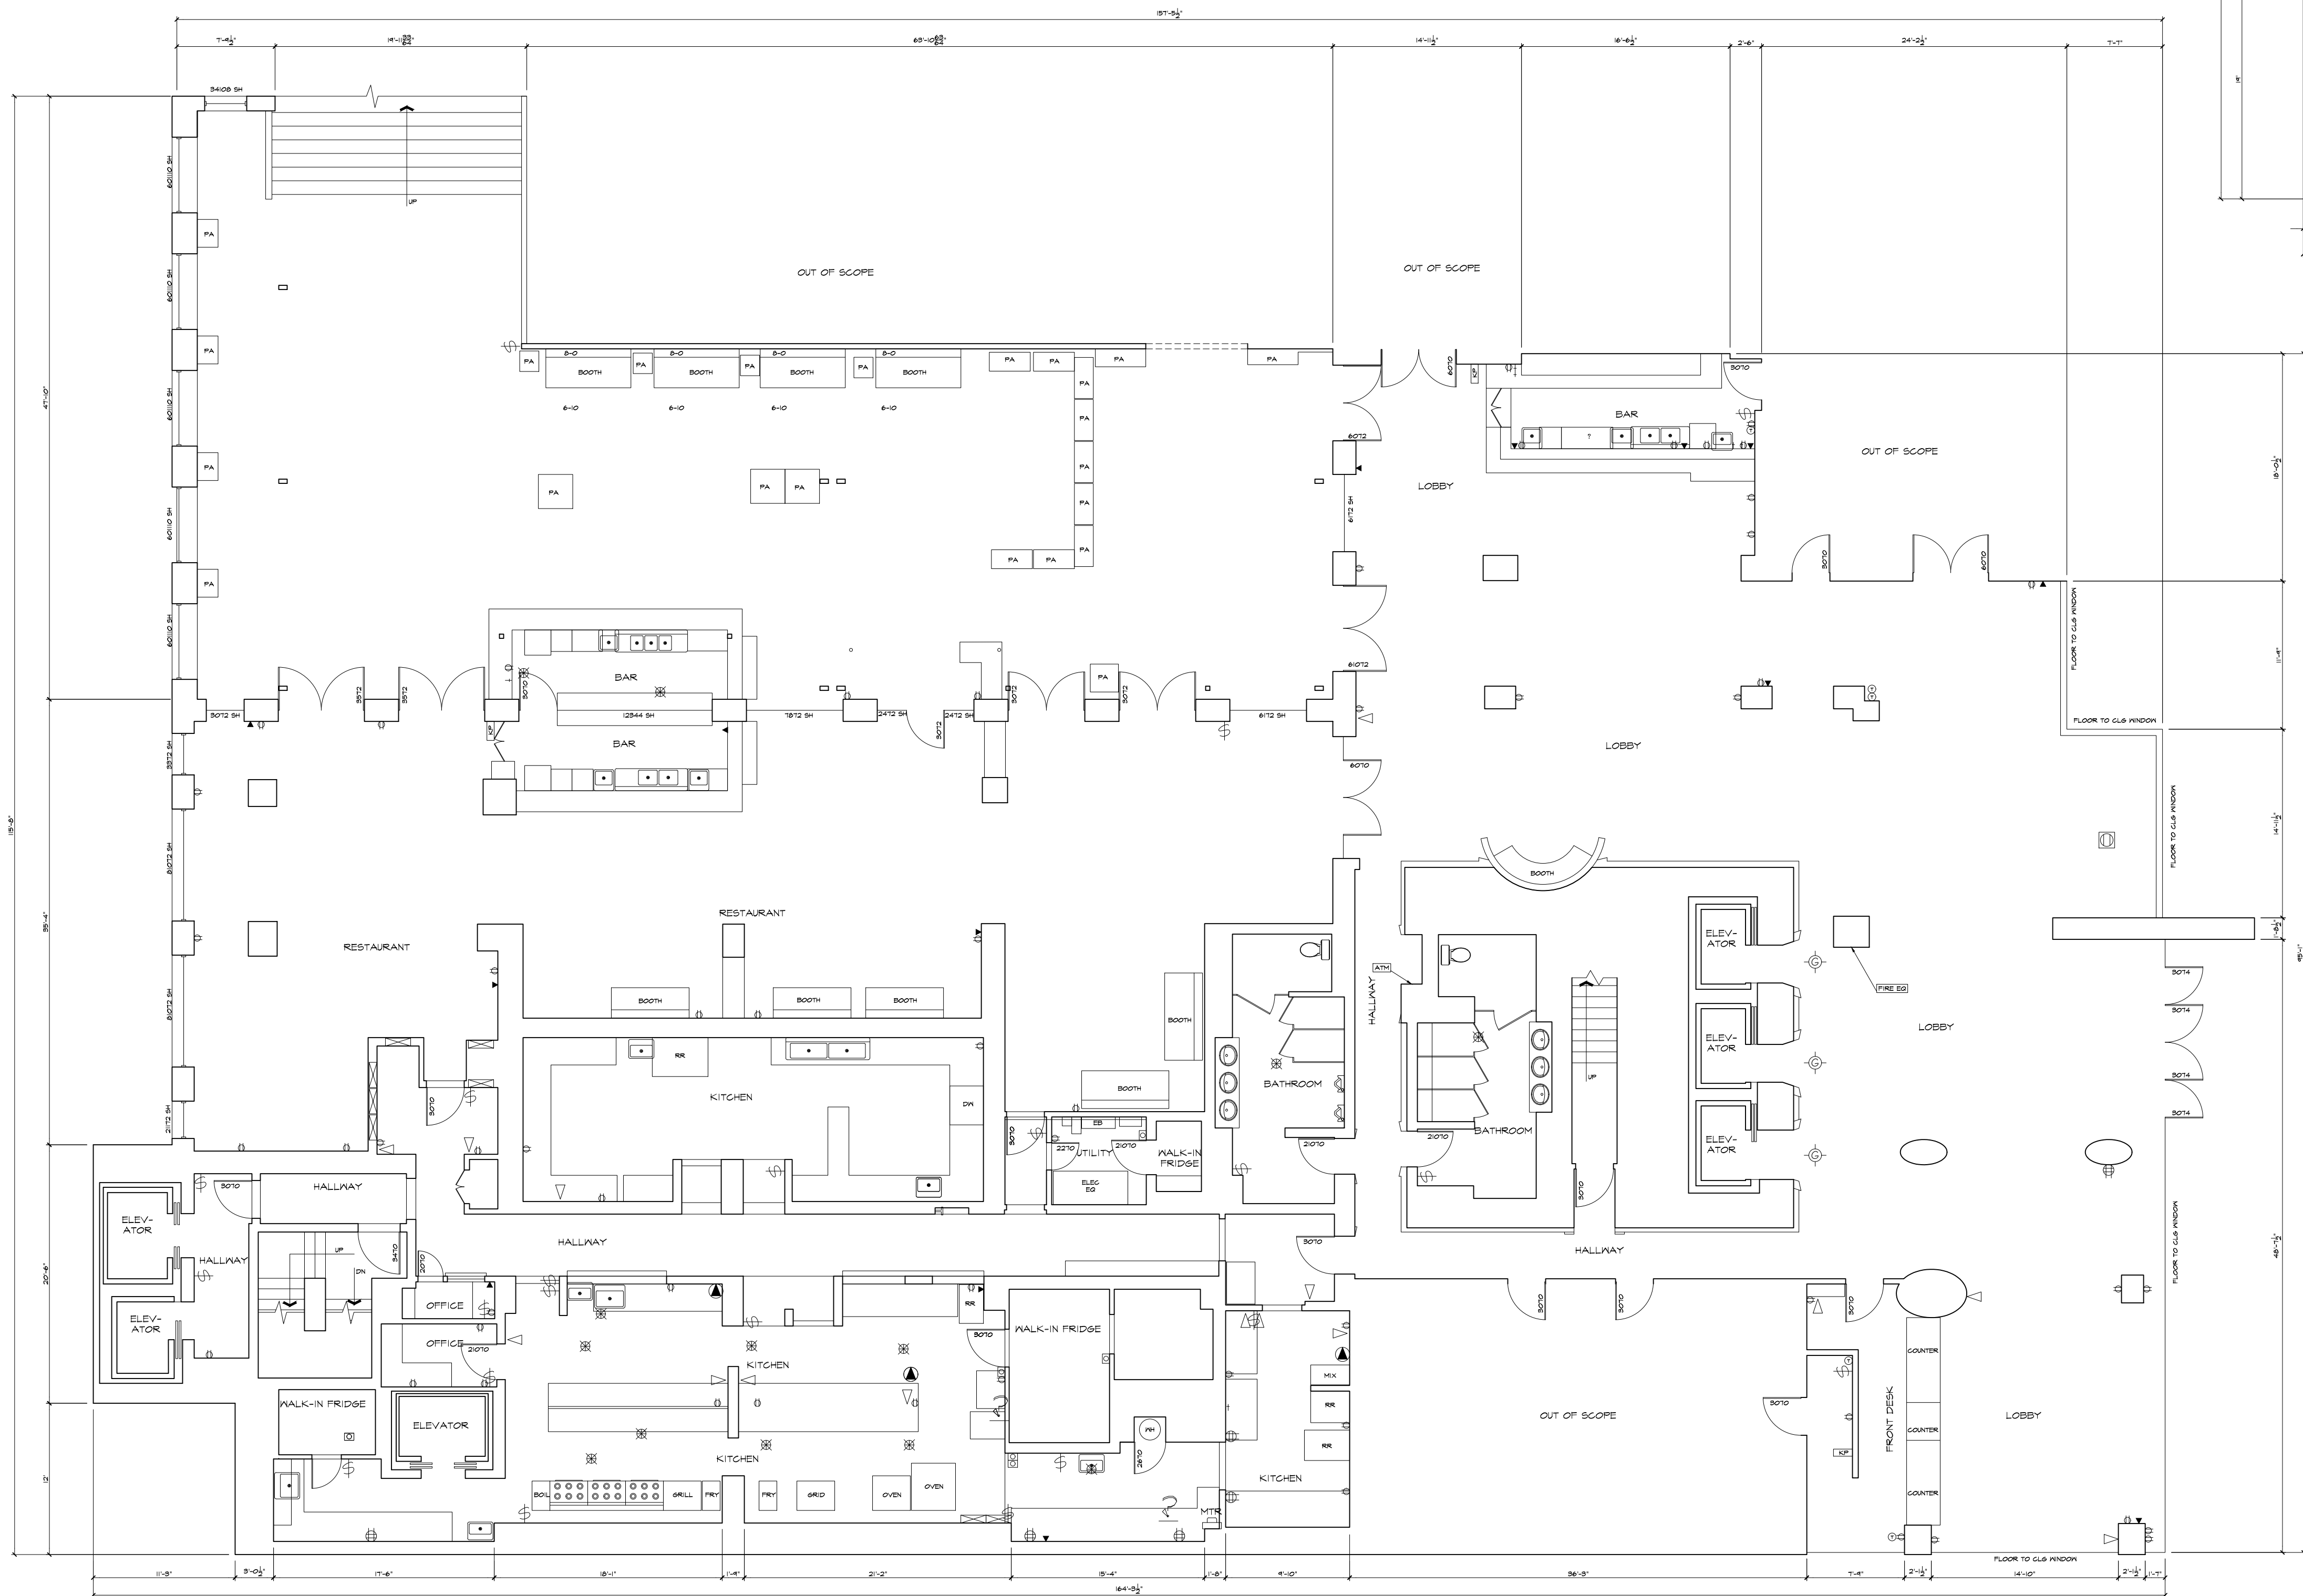

MAIN FLOOR 1/8"=1'-0"

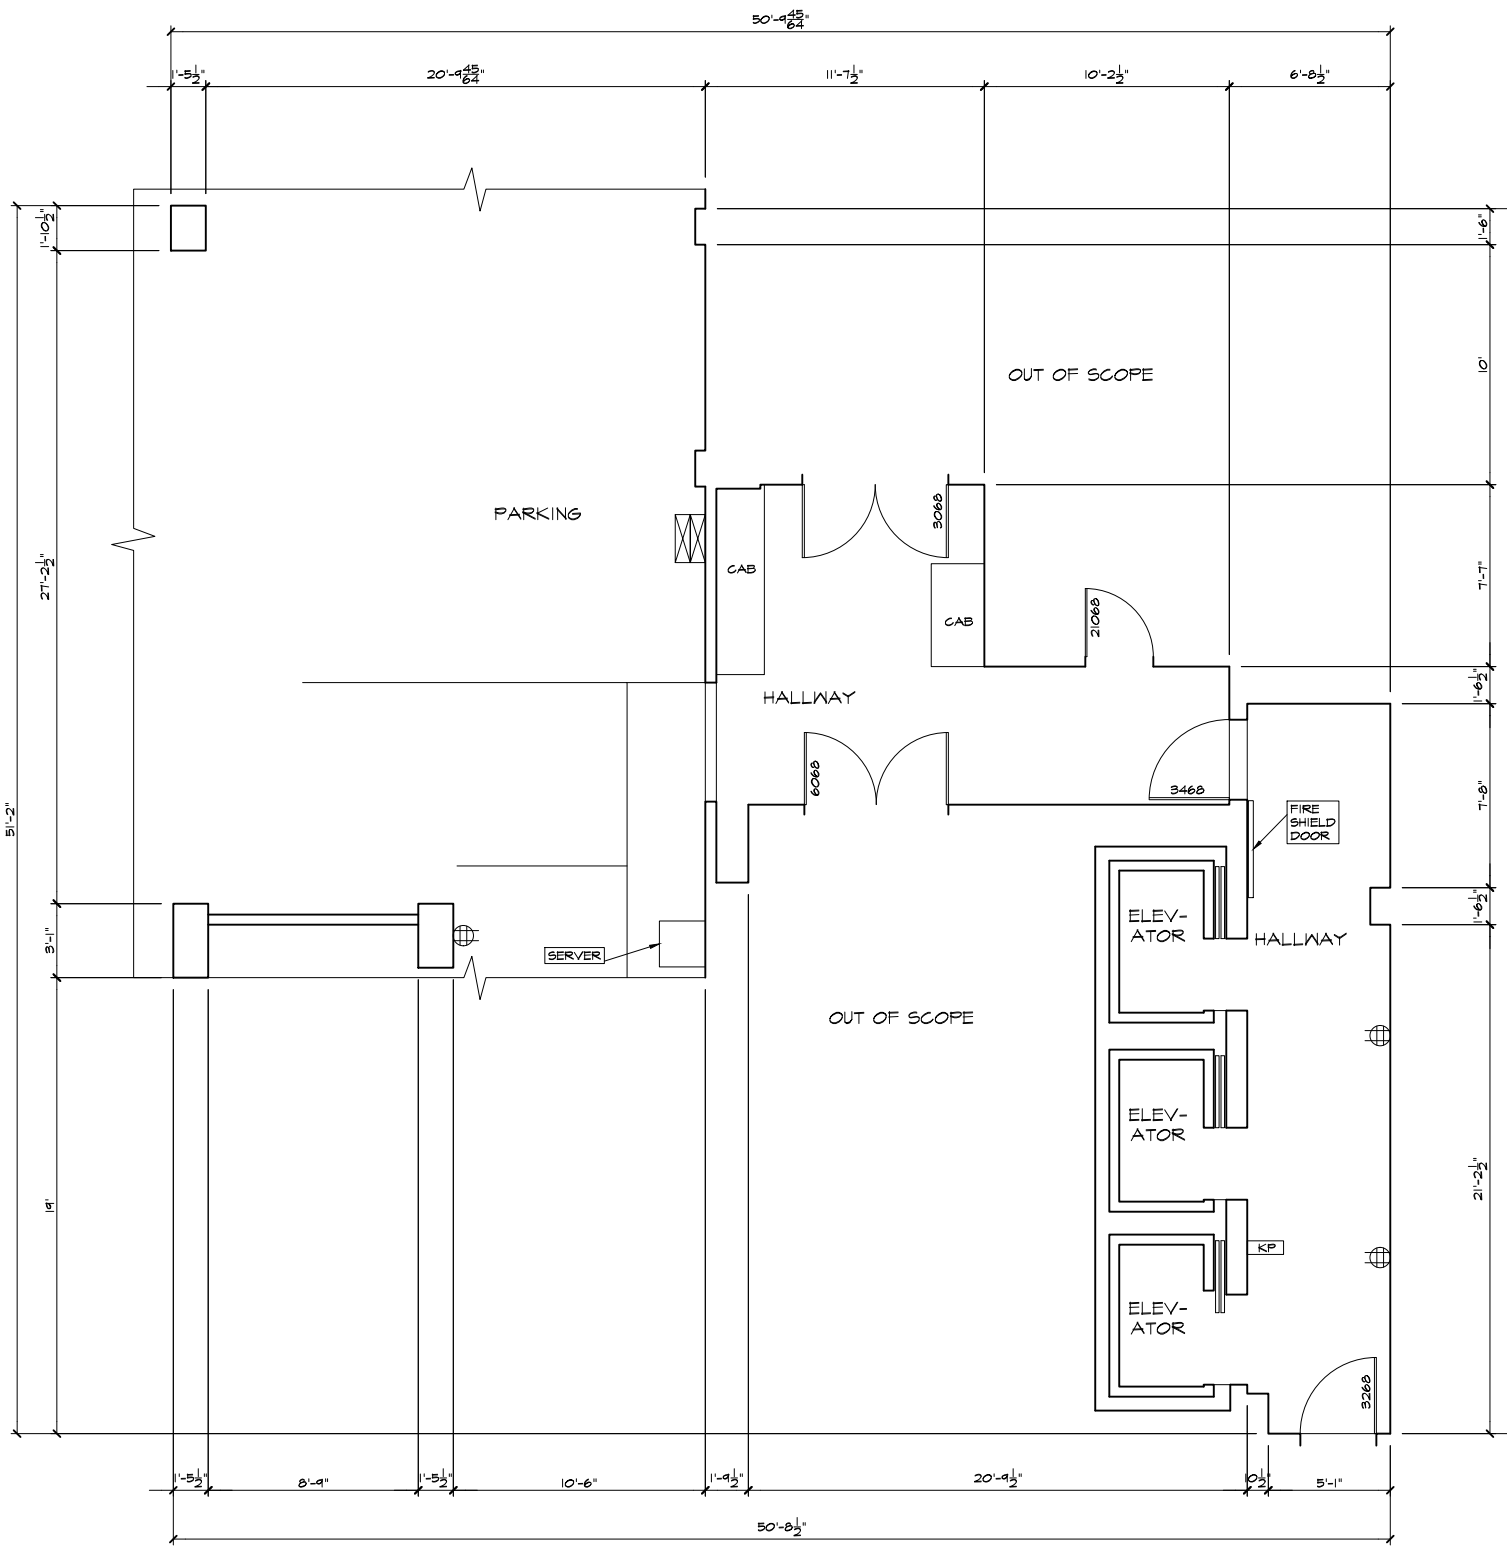

PARKING LEVEL 1/8"=1'-0"

As BUILT
PROFESSIONALS
www.asbuiltprofessionals.com

A DIVISION OF:



© 2020 AEC CONSULTANTS INC

ARCHITECTURAL AS BUILT
WEST HOLLYWOOD, CA 90069

01 100% SUBMISSION SEE COVER SHEET
NO. ISSUES | REVISIONS DATE

SHEET TITLE

MAIN FLOOR &
PARKING LEVEL
ELECTRICAL PLAN

HL PROJECT MANAGER
HL PROJECT DIRECTOR
012317-1 PROJECT NUMBER
1/8"=1'-0" SCALE
CL DRAWN BY
SHEET NUMBER

AB-7