

# AS-BUILT DOCUMENTATION

## DRAWING INDEX

- C-1 COVER SHEET | DRAWING INDEX
- SL SYMBOLS LEGEND
- AB-1 THIRD FLOOR PLAN - UNITS A-B & C
- AB-2 THIRD FLOOR RCP - UNITS A-B & C


**AS BUILT**  
PROFESSIONALS  
www.asbuiltprofessionals.com  
A DIVISION OF:

**AEC**  
CONSULTANTS INC

844.272.8458  
844 A S B U I L T

© 2019 AEC CONSULTANTS INC

# Nashville TN 37204

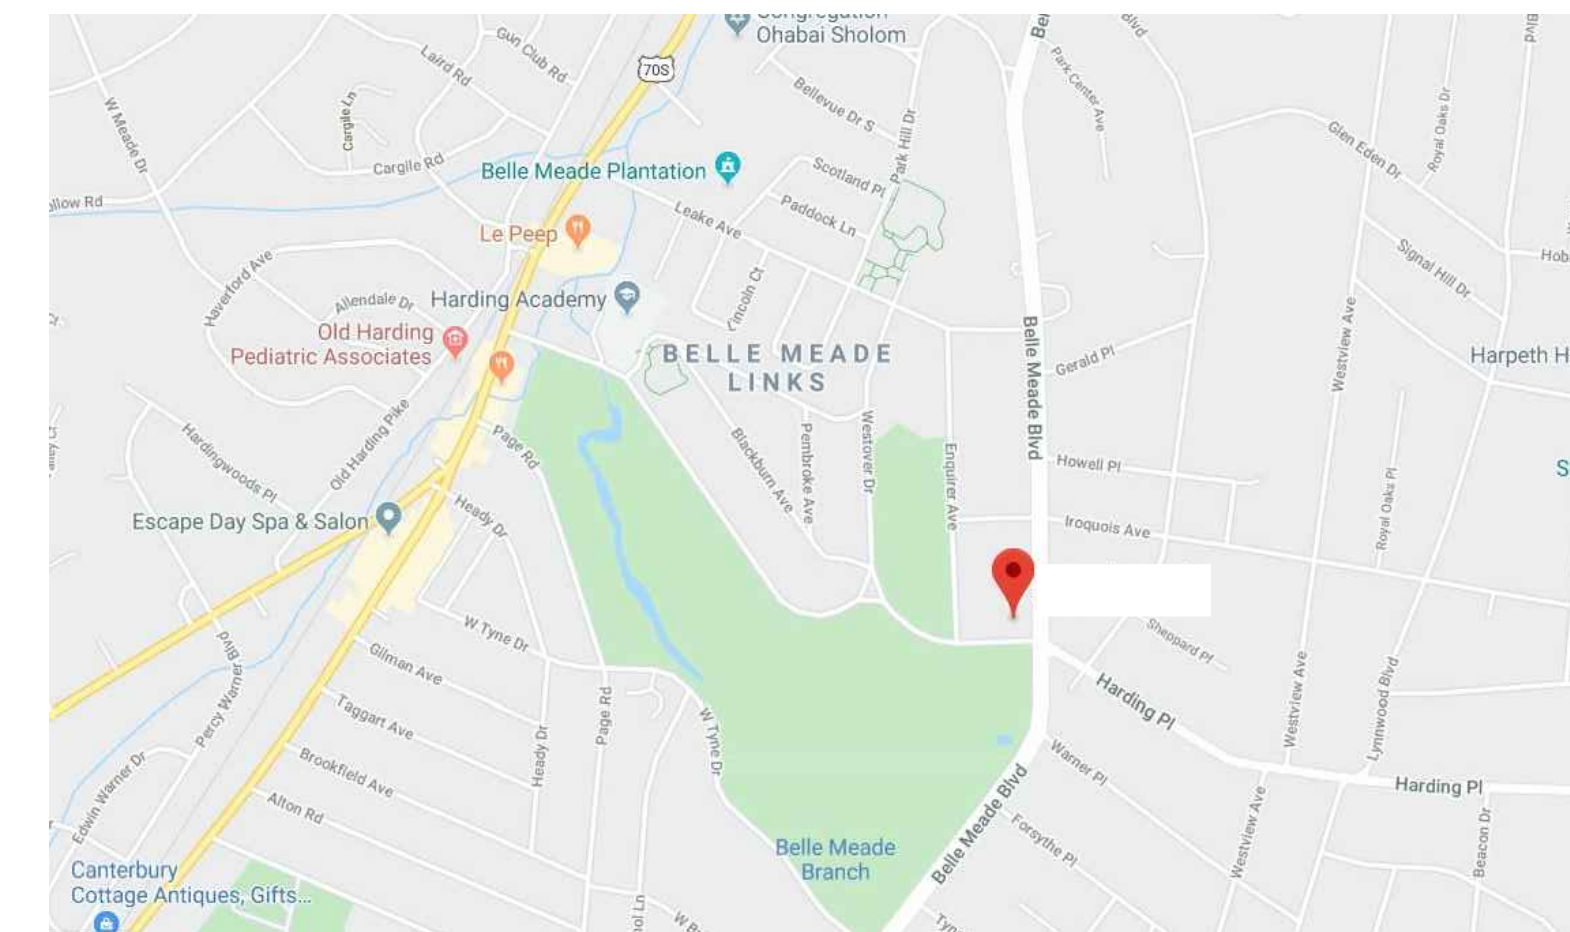

VICINITY MAP  
NTS

AREA DATA	
UNIT A-B	2425 SQ. FT. ±
UNIT C	1773 SQ. FT. ±
GRAND TOTAL	4198 SQ. FT. ±

**ARCHITECTURAL AS BUILT**

**Nashville TN 37204**

**100% SUBMITTAL**

01	100% SUBMISSION	SEE COVER SHEET
NO.	ISSUES   REVISIONS	DATE
SHEET TITLE		

**COVER SHEET**

HL	PROJECT MANAGER
HL	PROJECT DIRECTOR
012317-1	PROJECT NUMBER
	SCALE
CL	DRAWN BY
	SHEET NUMBER

**C1**

# SYMBOLS LEGEND

## RCP

- |  |  |  |                              |
|--|--|--|------------------------------|
|  | EXHAUST VENT                                 |  | TRACK LIGHT OR VANITY LIGHT  |
|  | CEILING MOUNTED LIGHT FIXTURE                |  | WALL-MOUNTED LIGHT FIXTURE   |
|  | CEILING MOUNTED DIRECTIONAL LIGHT            |  | EMERGENCY EXIT SIGN          |
|  | RECESSED CAN LIGHT                           |  | EMERGENCY EXIT LIGHT         |
|  | EYEBALL OR SMALL CAN LIGHT                   |  | EMERGENCY EXIT LIGHT W/ SIGN |
|  | PENDANT LIGHT                                |  | LIGHTED STAIR SIGN           |
|  | INDIVIDUAL FLUOR. LAY-IN FIXTURE 4 BULB      |  | FLOOD LIGHT                  |
|  | INDIVIDUAL FLUOR. HANGING FIXTURE 2 BULB     |  | PHOTO CELL                   |
|  | INDIVIDUAL FLUOR. FLUSH MOUNT FIXTURE 4 BULB |  | CEILING FAN                  |
|  | CAMERA                                       |  | CEILING FAN W/ LIGHT KIT     |
|  | MOTION DET.                                  |  |                              |
|  | SUPPLY VENT                                  |  |                              |
|  | RETURN VENT                                  |  |                              |
|  | SPEAKER                                      |  |                              |

7-2-6  
 CEILING HEIGHT AND TRIM 7'-2" ABOVE FLOOR BELOW WITH 6" CROWN MOULDING. NOTE: ALL CEILING NOT LABELED ARE PLASTER. CEILING SHOWN WITH A GRID ARE LAY IN ACOUSTICAL TILE..

## ELECTRIC

- |  |                                      |
|--|--------------------------------------|
|  | DATA OUTLET                          |
|  | TELEPHONE JACK                       |
|  | ELECTRIC SWITCH                      |
|  | CABLE TELEVISION OUTLET              |
|  | DUPLEX RECEPTACLE OUTLET             |
|  | SPECIAL PURPOSE CONNECTION OR OUTLET |
|  | QUADRUPLEX RECEPTACLE OUTLET         |
|  | FLOOR DUPLEX RECEPTACLE OUTLET       |
|  | ELECTRIC PANEL                       |
|  | ELECTRIC METER                       |
|  | BUTTON SWITCH                        |
|  | DISCONNECT SWITCH                    |
|  | GROUND/FLOOR LIGHT                   |
|  | KEY PAD                              |

## FIRE PROTECTION




- |  |                              |
|--|------------------------------|
|  | FIRE EXTINGUISHER            |
|  | FIRE PULL                    |
|  | FIRE ALARM (HORN/SRTOBE)     |
|  | SMOKE DETECTOR               |
|  | SMOKE ALARM SPEAKER          |
|  | SPRINKLER HEAD CEILING MOUNT |
|  | SPRINKLER HEAD WALL MOUNT    |

## MEP

- |  |                      |
|--|----------------------|
|  | THERMOSTAT           |
|  | FLOOR DRAIN          |
|  | VALVE                |
|  | HOSE BIB             |
|  | WATER SUPPLY         |
|  | SUSPENDED GAS HEATER |

## MISC

- |  |                |
|--|----------------|
|  | BOLLARD        |
|  | SPOT ELEVATION |

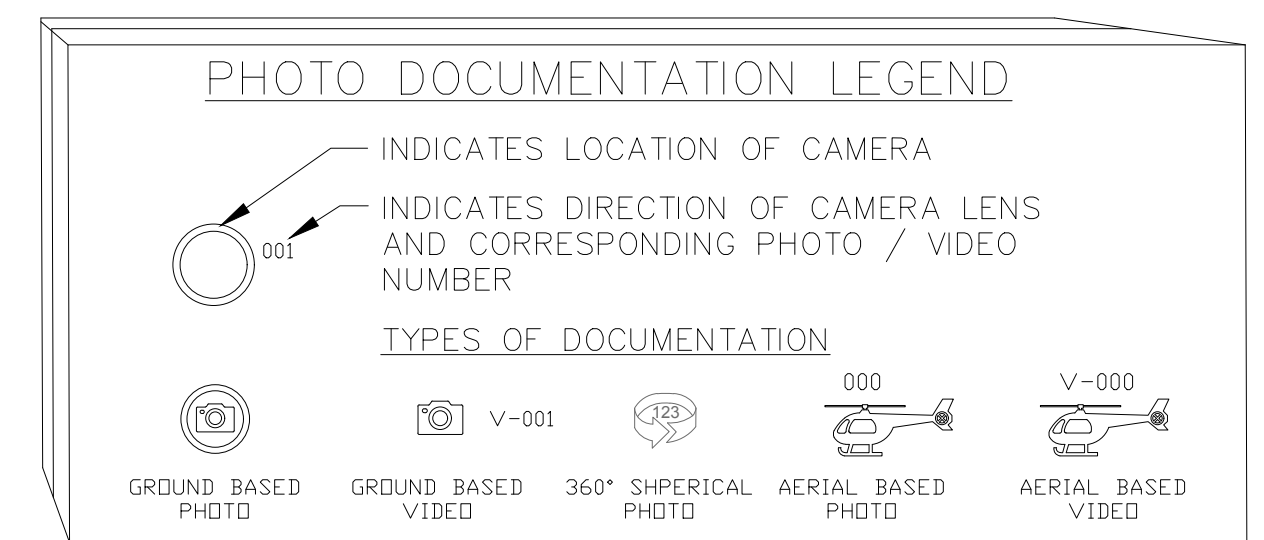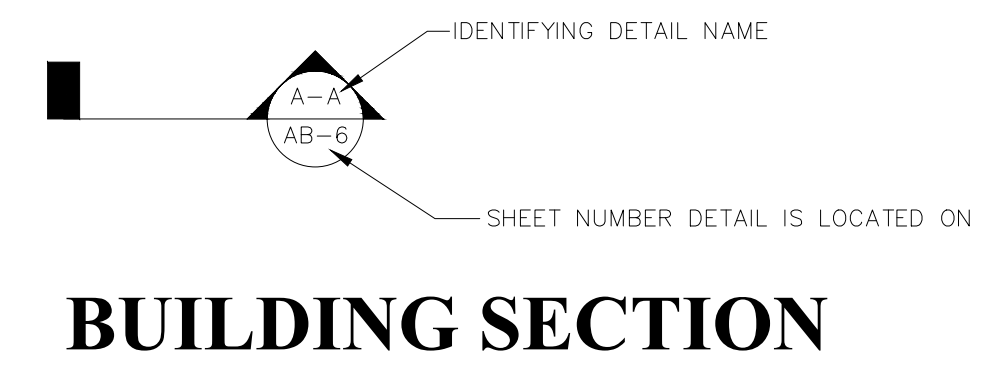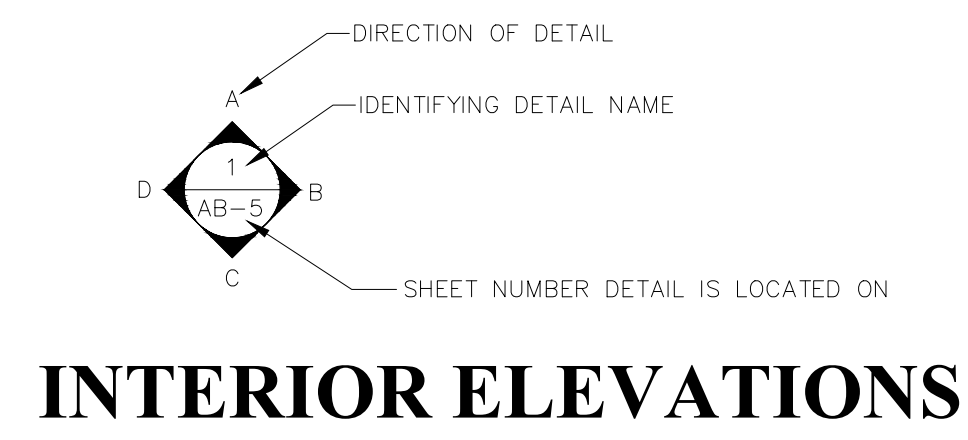

**ARCHITECTURAL AS BUILT**  
**Nashville TN 37204**



01	100% SUBMISSION	SEE COVER SHEET
NO.	ISSUES   REVISIONS	DATE

**SYMBOL LEGEND**

HL	PROJECT MANAGER
HL	PROJECT DIRECTOR
012317-1	PROJECT NUMBER
	SCALE
CL	DRAWN BY
	SHEET NUMBER

**SL**

**ARCHITECTURAL AS BUILT**  
**Nashville TN 37204**

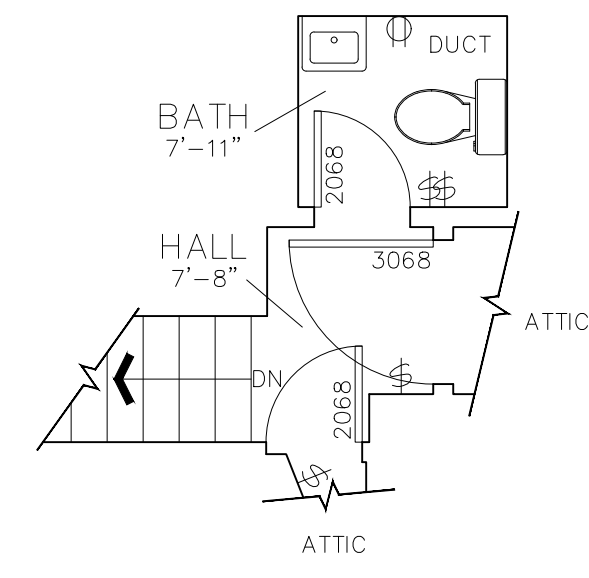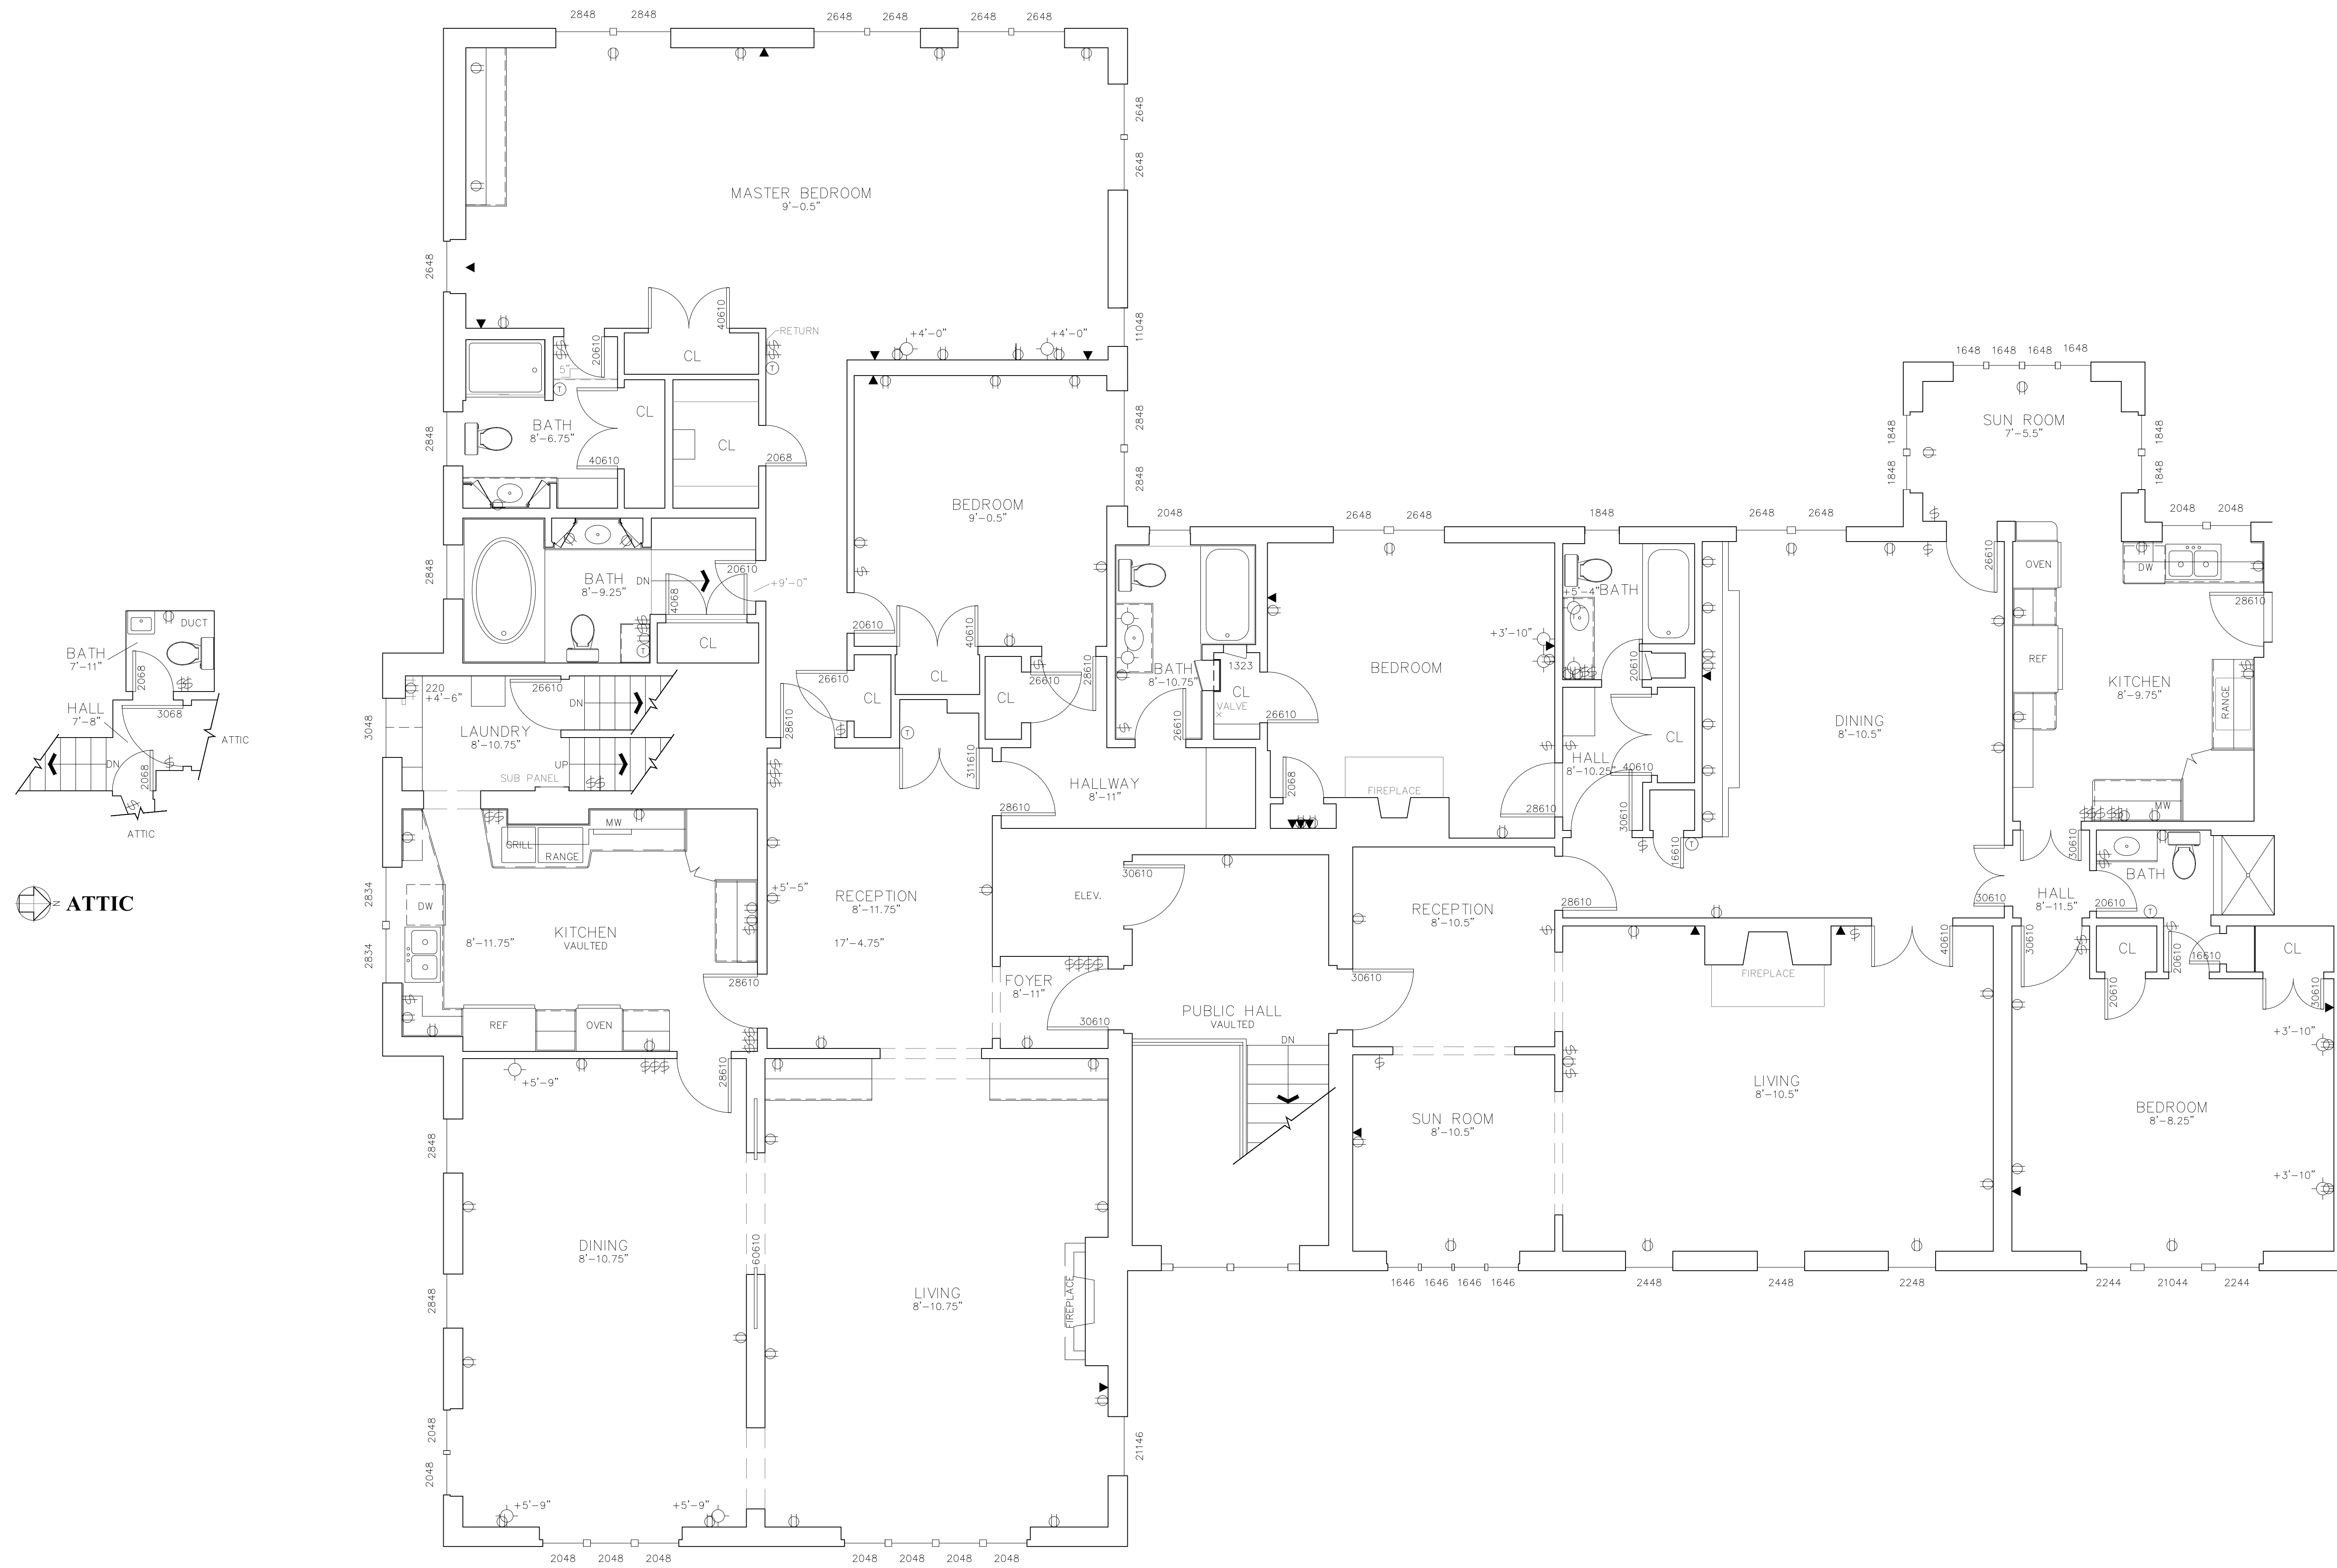

ATTIC

THIRD FLOOR



01	100% SUBMISSION	SEE COVER SHEET
NO.	ISSUES   REVISIONS	DATE
		SHEET TITLE

**THIRD FLOOR PLAN**

HL	PROJECT MANAGER
HL	PROJECT DIRECTOR
012317-1	PROJECT NUMBER
1/4"=1'-0"	SCALE
CL	DRAWN BY
	SHEET NUMBER

**AB-1**

**ARCHITECTURAL AS BUILT**  
**Nashville TN 37204**

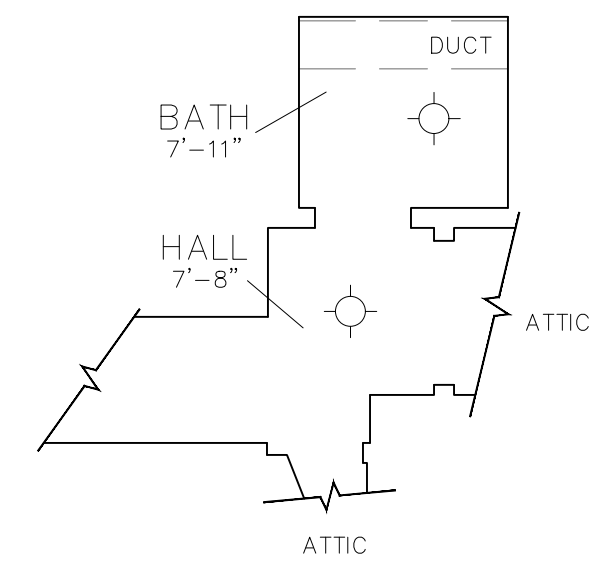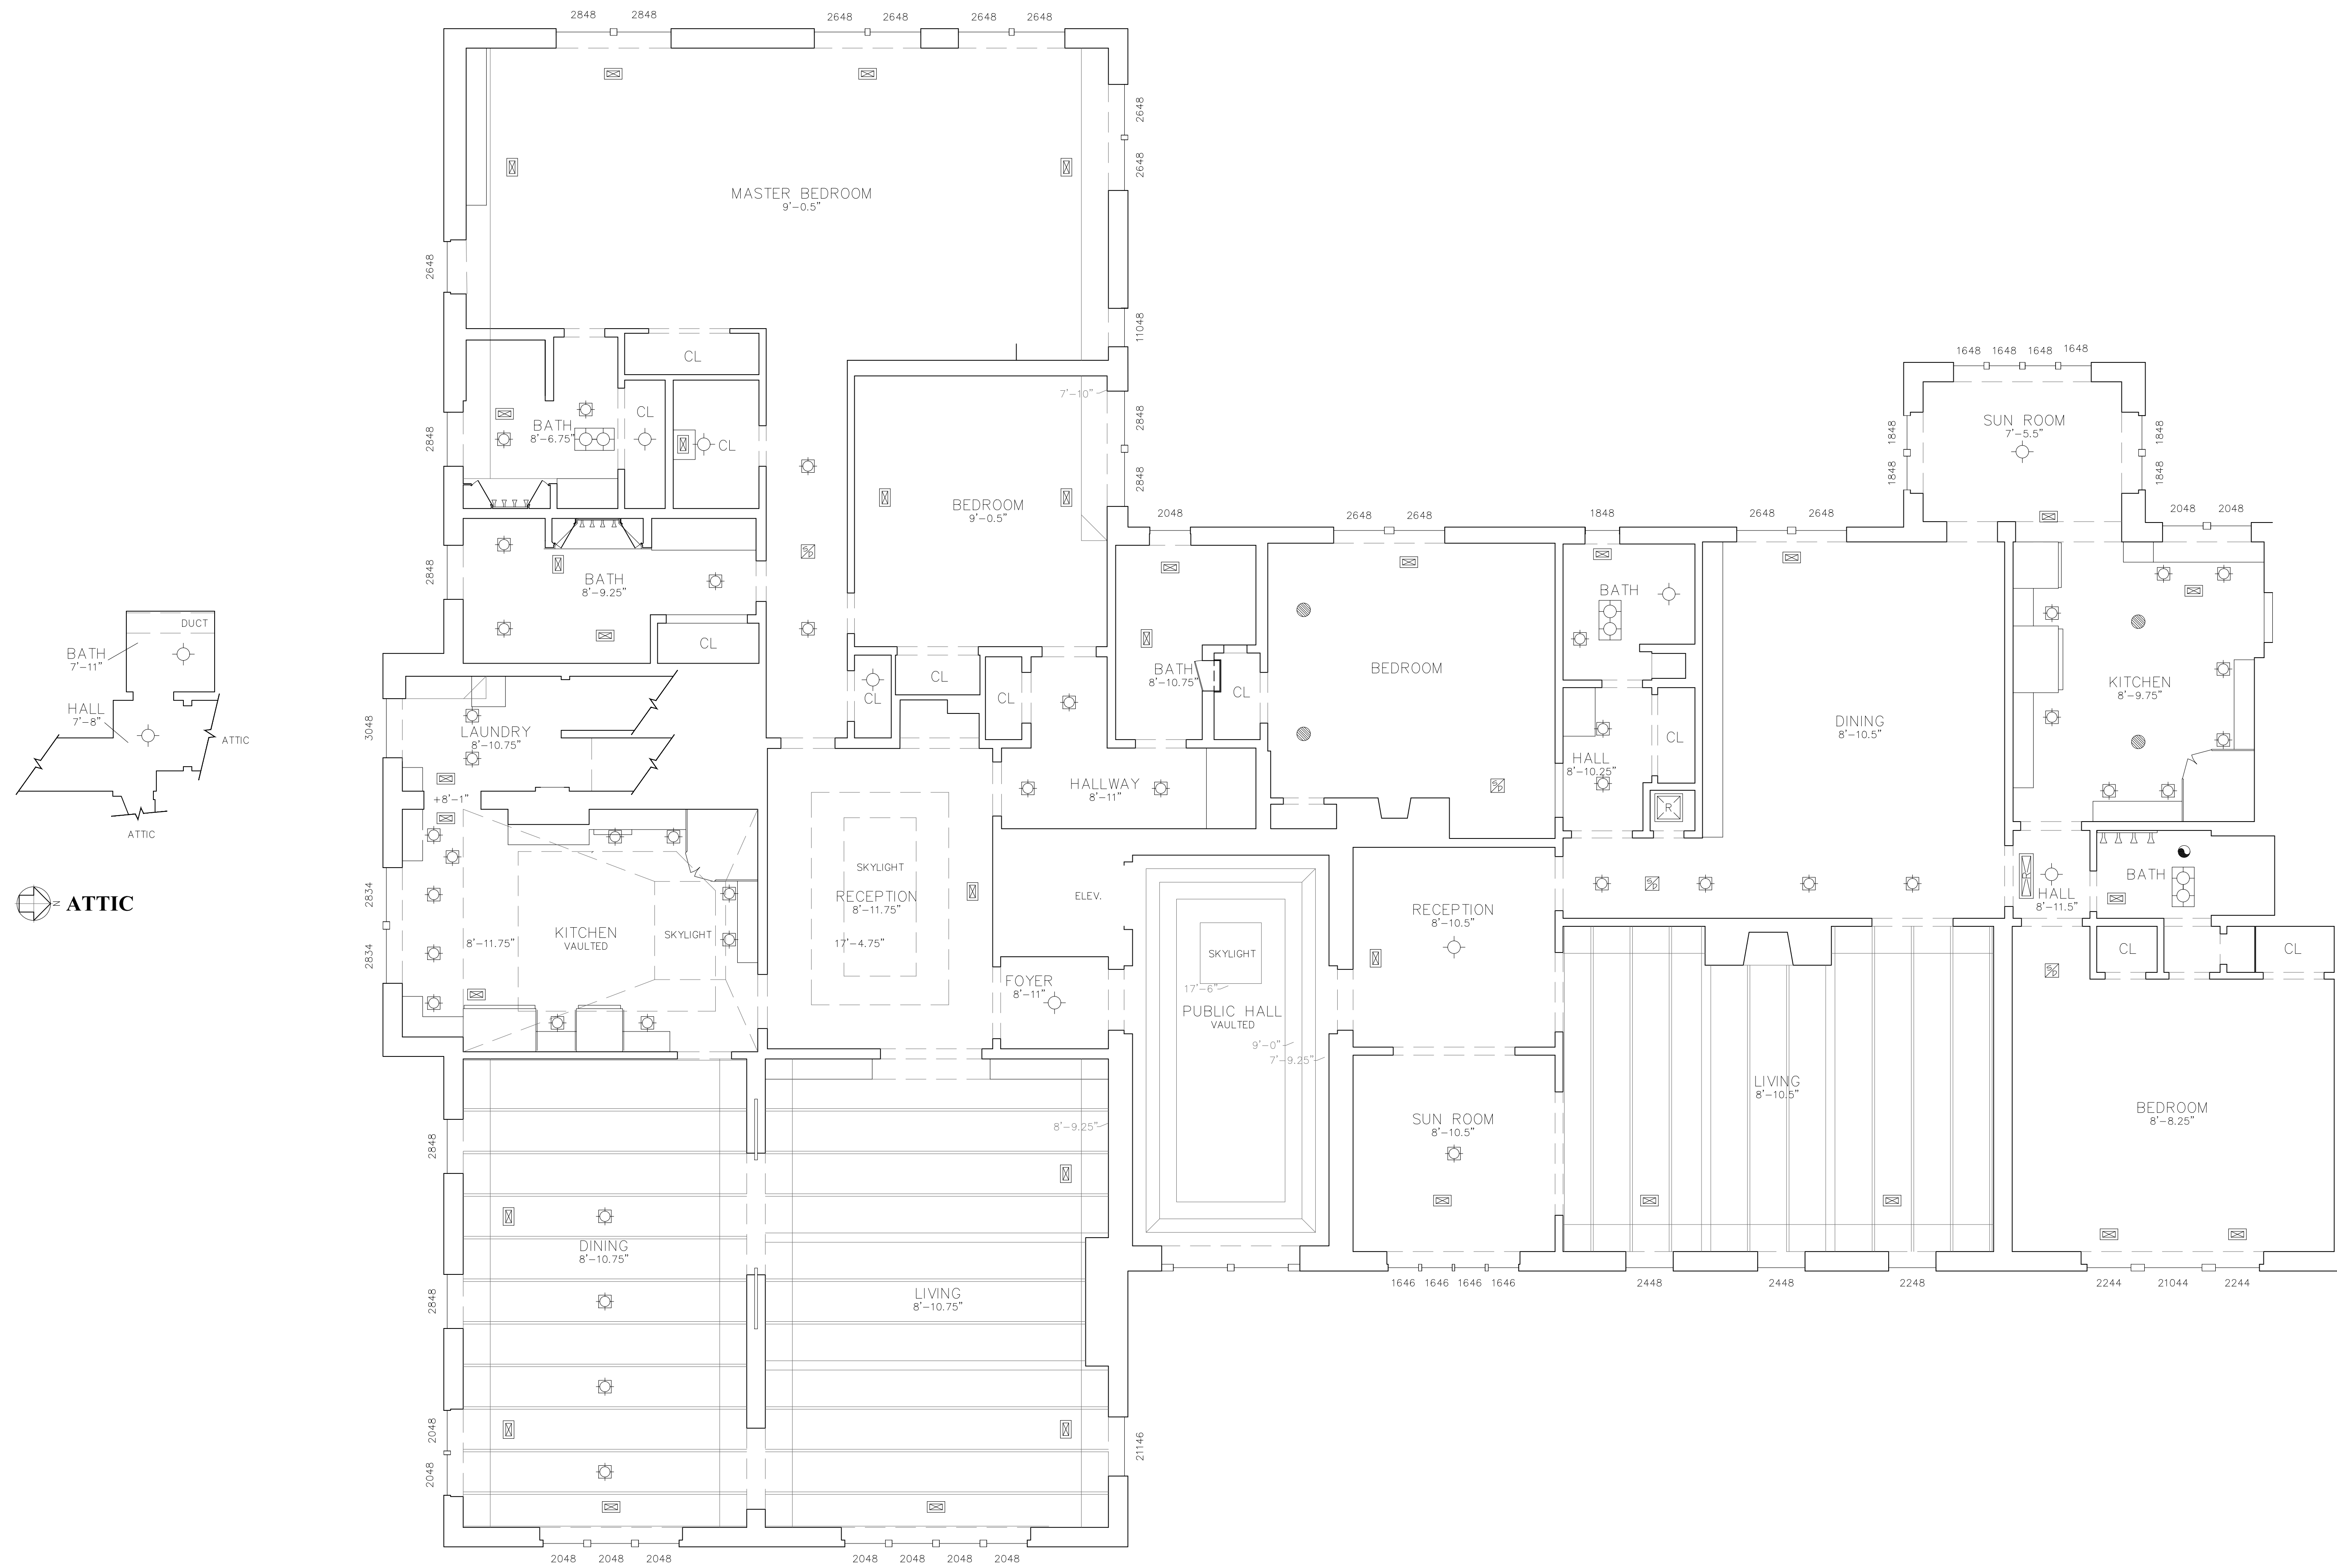

**THIRD FLOOR**

01	100% SUBMISSION	SEE COVER SHEET
NO.	ISSUES   REVISIONS	DATE
SHEET TITLE		

**REFLECTED CEILING PLAN**

HL	PROJECT MANAGER
HL	PROJECT DIRECTOR
012317-1	PROJECT NUMBER
<b>1/4"=1'-0"</b>	SCALE
CL	DRAWN BY
	SHEET NUMBER

**AB-2**