

# AS-BUILT DOCUMENTATION


## Saint Helena, CA 94575



**100% SUBMITTAL**

### DRAWING INDEX

- C-1 COVER SHEET | DRAWING INDEX
- SL SYMBOLS LEGEND
- AB-1 BASEMENT
- AB-2 FIRST FLOOR
- AB-3 SECOND FLOOR

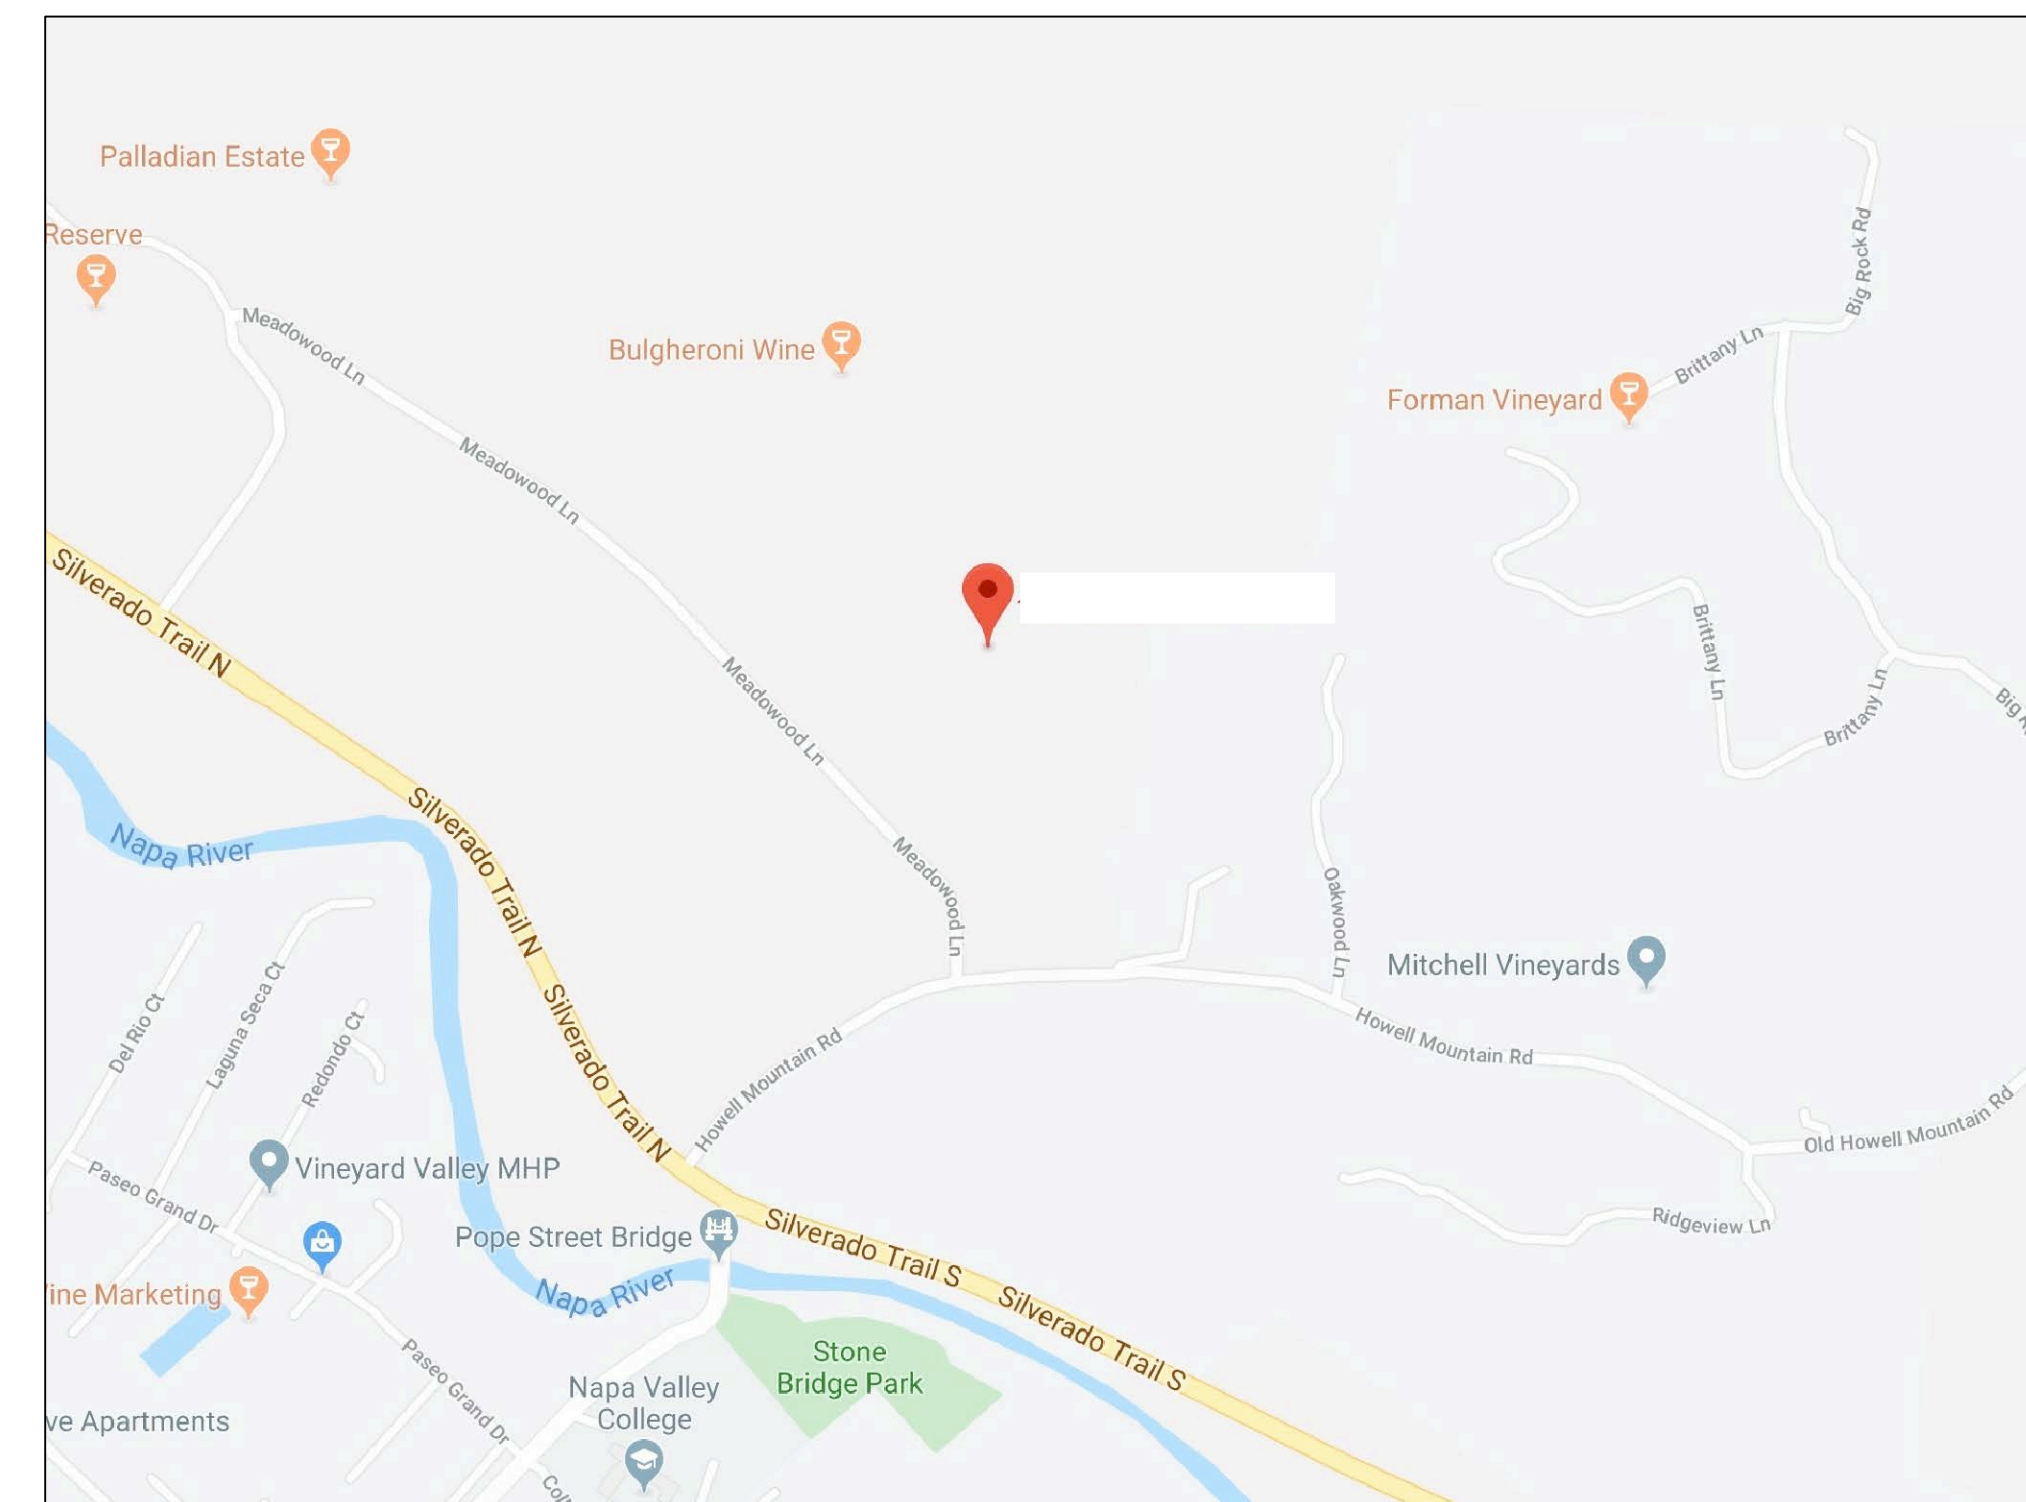

**VICINITY MAP**  
NTS

GROSS AREA DATA	
BASEMENT AND GARAGE	2,131 S.F.
FIRST FLOOR	3,305 S.F.
SECOND FLOOR	2,038 S.F.
SUBTOTAL	7,474 S.F.
RAISED ENTRY WITH TRELLIS	1,090 S.F.
CRAWL SPACE WITH UTILITIES	1,522 S.F.
<b>GROSS AREA DOCUMENTED</b>	<b>10,089 S.F.</b>



**ARCHITECTURAL AS BUILT**  
**Saint Helena, CA 94575**

01	100% SUBMISSION	SEE COVER SHEET
NO.	ISSUES   REVISIONS	DATE
		SHEET TITLE

**COVER SHEET**

HL	PROJECT MANAGER
HL	PROJECT DIRECTOR
012317-1	PROJECT NUMBER
	SCALE
CL	DRAWN BY
	SHEET NUMBER

**C-1**



# SYMBOLS LEGEND

## RCP

	EXHAUST VENT		TRACK LIGHT OR VANITY LIGHT
	CEILING MOUNTED LIGHT FIXTURE		WALL-MOUNTED LIGHT FIXTURE
	CEILING MOUNTED DIRECTIONAL LIGHT		EMERGENCY EXIT SIGN
	RECESSED CAN LIGHT		EMERGENCY EXIT LIGHT
	EYEBALL OR SMALL CAN LIGHT		EMERGENCY EXIT LIGHT W/ SIGN
	PENDANT LIGHT		LIGHTED STAIR SIGN
	INDIVIDUAL FLUOR. LAY-IN FIXTURE 4 BULB		FLOOD LIGHT
	INDIVIDUAL FLUOR. HANGING FIXTURE 2 BULB		PHOTO CELL
	INDIVIDUAL FLUOR. FLUSH MOUNT FIXTURE 4 BULB		CEILING FAN
	CAMERA		CEILING FAN W/ LIGHT KIT
	MOTION DET.		7-2-6 CEILING HEIGHT AND TRIM 1'-2" ABOVE FLOOR BELOW WITH 6" CROWN MOULDING. NOTE: ALL CEILINGS NOT LABELED ARE PLASTER. CEILINGS SHOWN WITH A GRID ARE LAY IN ACOUSTICAL TILE..
	SUPPLY VENT		JUNCTION BOX
	SUPPLY VENT		
	RETURN VENT		
	RETURN VENT		
	SPEAKER		

## ELECTRIC

	DATA OUTLET
	TELEPHONE JACK
	ELECTRIC SWITCH
	CABLE TELEVISION OUTLET
	DUPLEX RECEPTACLE OUTLET
	SPECIAL PURPOSE CONNECTION OR OUTLET
	QUADRUPLIX RECEPTACLE OUTLET
	FLOOR DUPLEX RECEPTACLE OUTLET
	ELECTRIC PANEL
	ELECTRIC METER
	BUTTON SWITCH
	DISCONNECT SWITCH
	GROUND/FLOOR LIGHT
	KEY PAD

## FIRE PROTECTION


	FIRE EXTINGUISHER
	FIRE PULL
	FIRE ALARM (HORN/SRTOBE)
	SMOKE DETECTOR
	SMOKE ALARM SPEAKER
	SPRINKLER HEAD CEILING MOUNT
	SPRINKLER HEAD WALL MOUNT

## MEP


	THERMOSTAT
	FLOOR DRAIN
	VALVE
	HOSE BIB
	WATER SUPPLY
	SUSPENDED GAS HEATER

## MISC

	BOLLARD
	11-4-11/16 SPOT ELEVATION

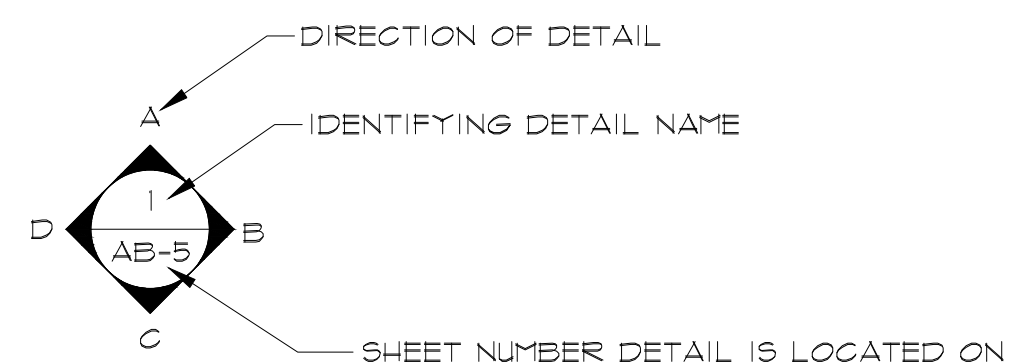


## INTERIOR ELEVATIONS

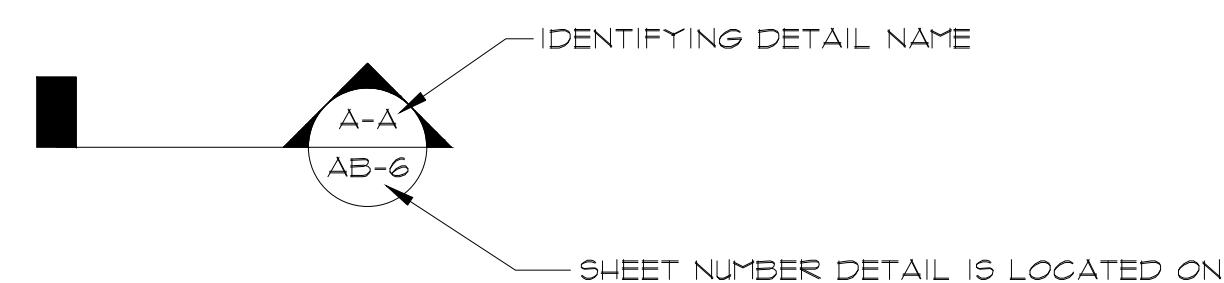

## BUILDING SECTION

## PHOTO DOCUMENTATION LEGEND

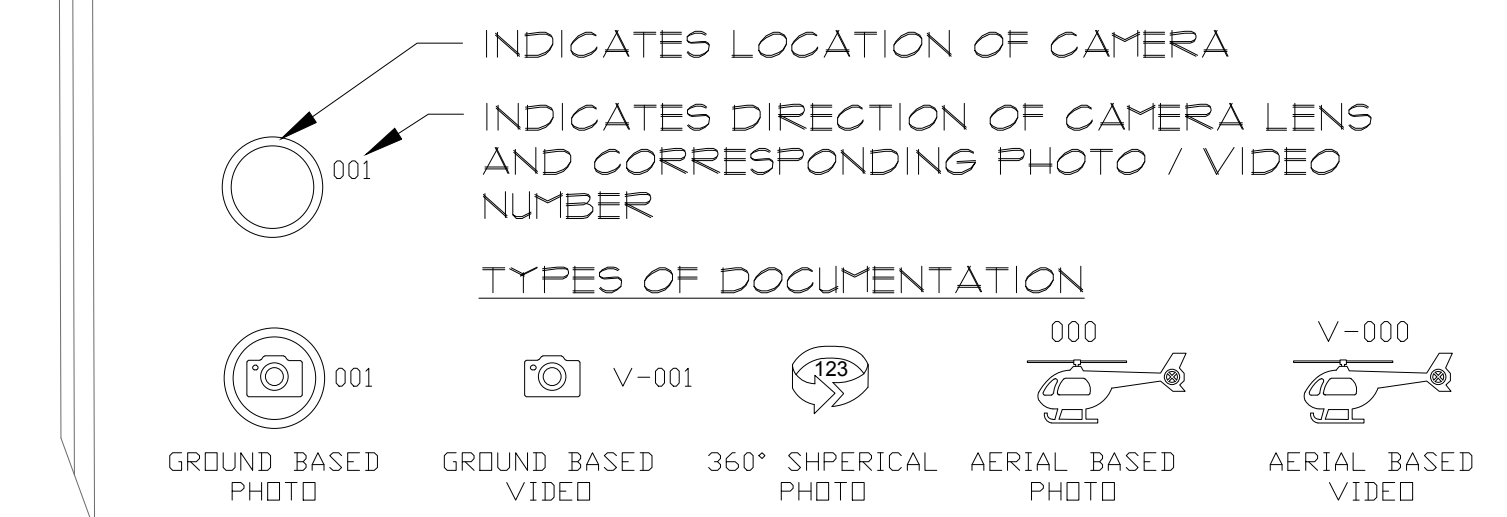


**ARCHITECTURAL AS BUILT**  
**Saint Helena, CA 94575**

01	100% SUBMISSION	SEE COVER SHEET
NO.	ISSUES   REVISIONS	DATE
SHEET TITLE		

HL	PROJECT MANAGER
HL	PROJECT DIRECTOR
012317-1	PROJECT NUMBER
<b>NOT TO SCALE</b>	SCALE
CL	DRAWN BY
	SHEET NUMBER

**SL**

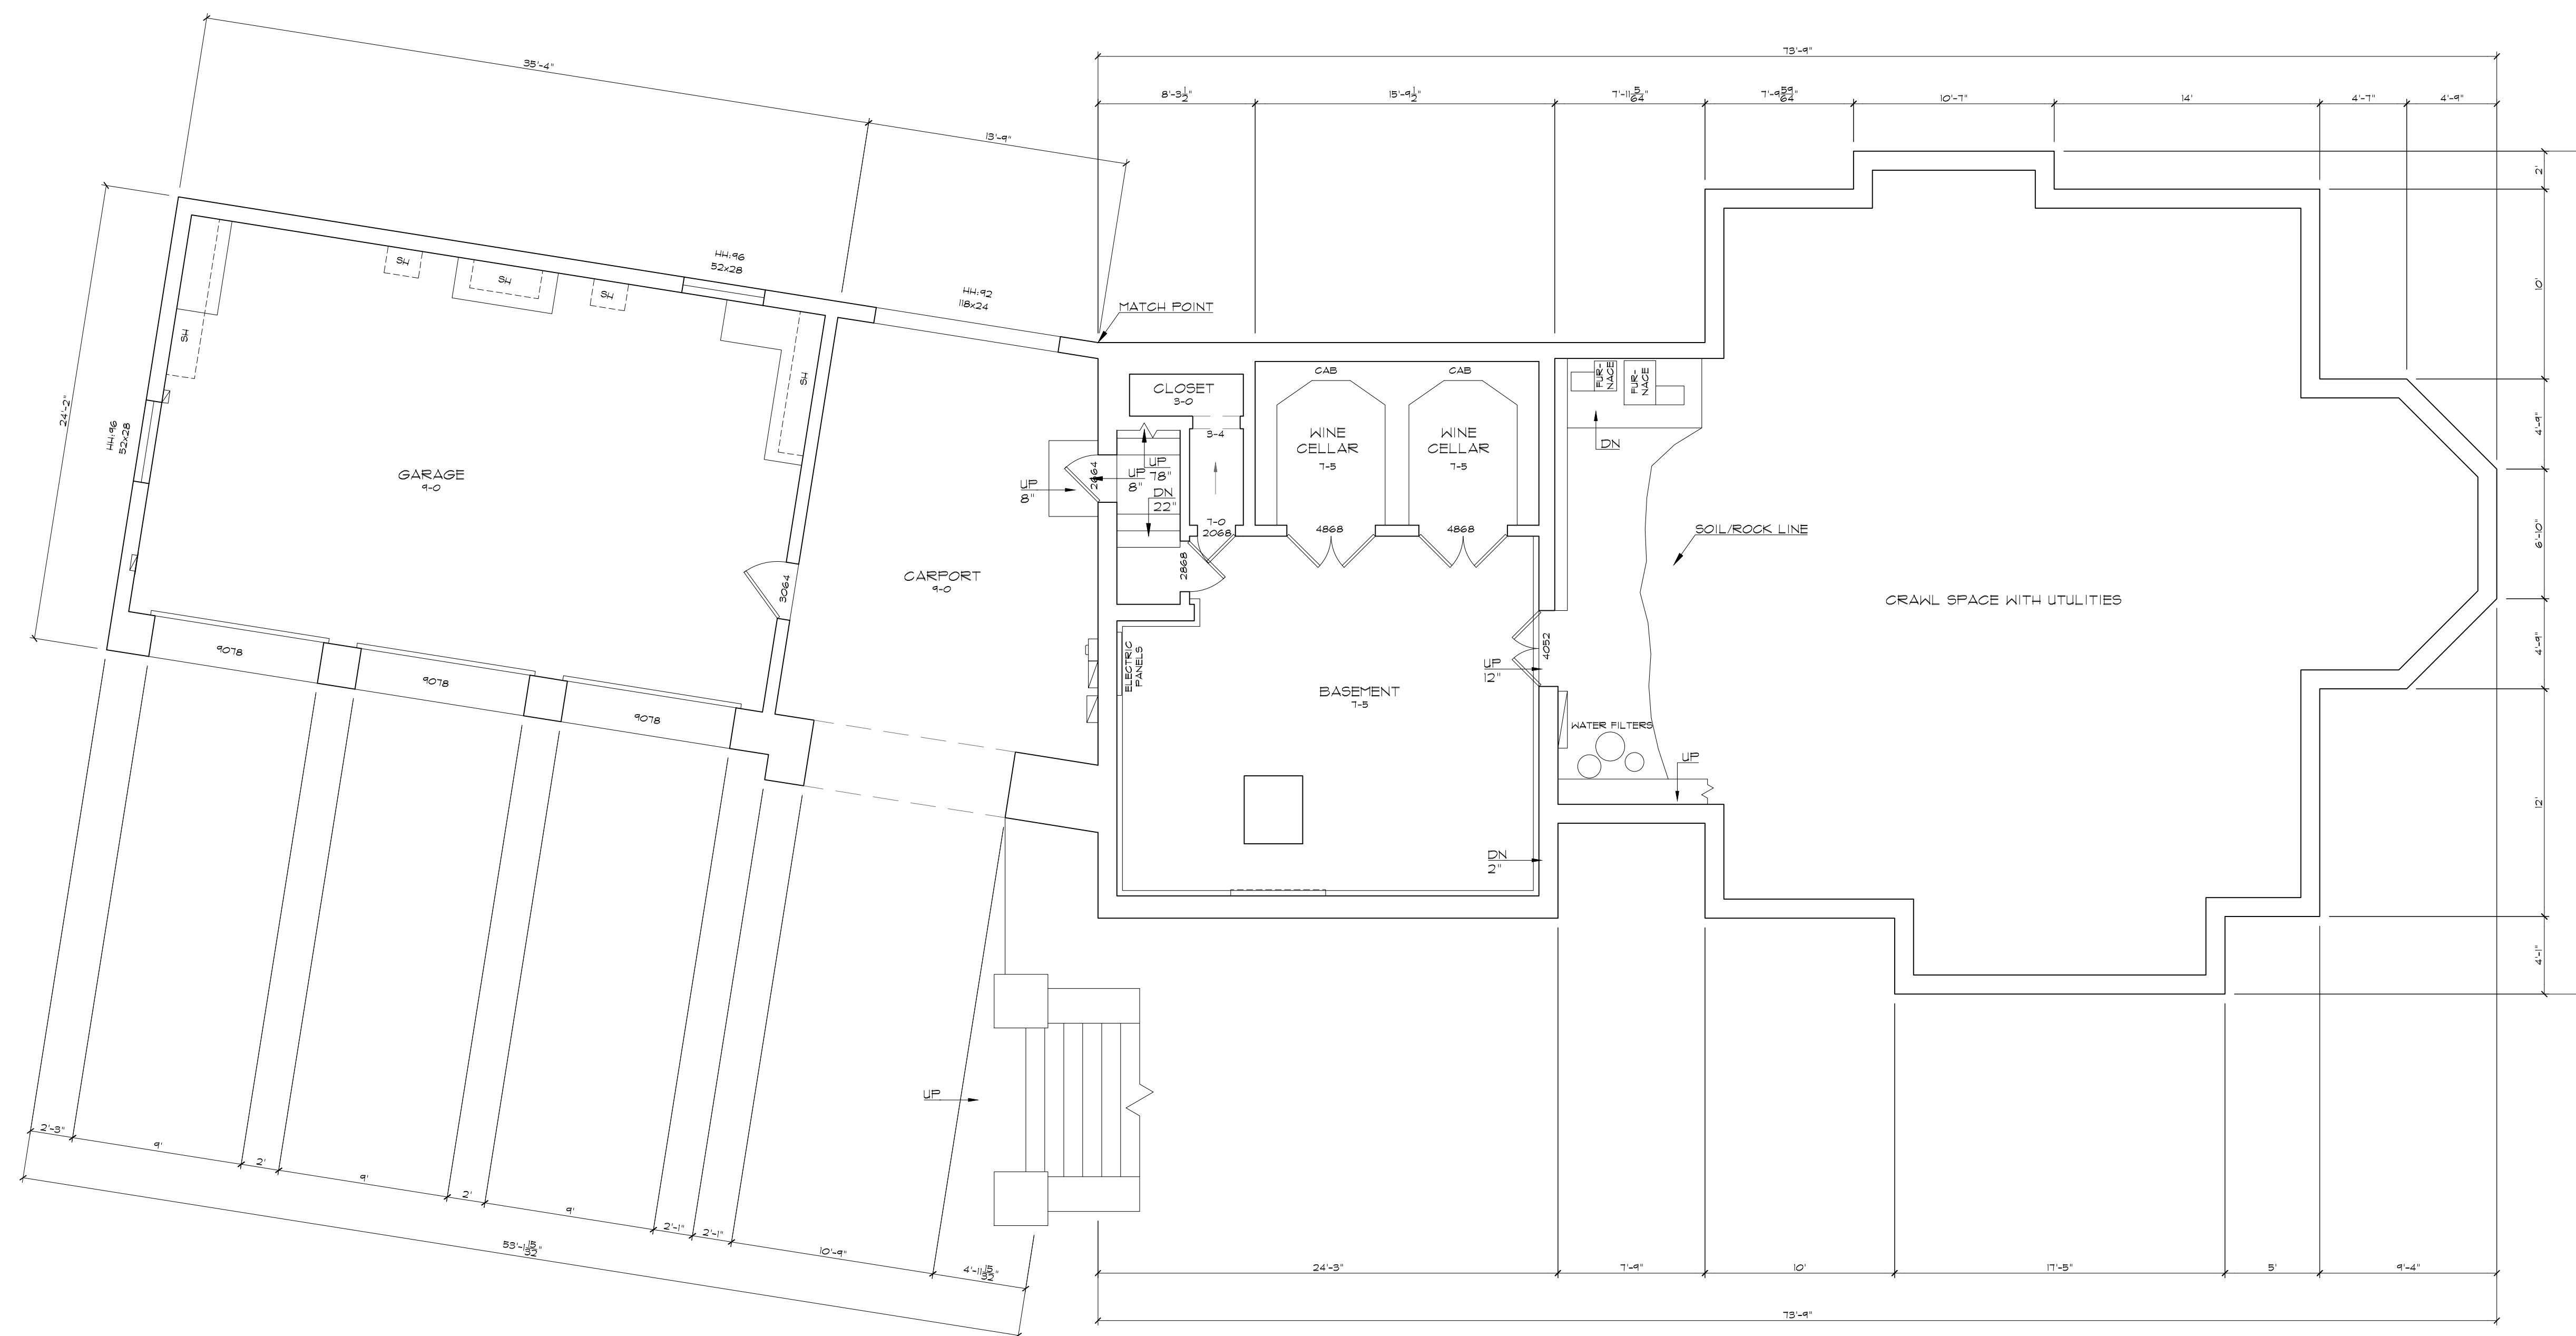

BASEMENT FLOOR PLAN 3/16"=1'-0"

**ARCHITECTURAL AS BUILT**  
**Saint Helena, CA 94575**

01	100% SUBMISSION	SEE COVER SHEET
NO.	ISSUES   REVISIONS	DATE

SHEET TITLE

HL PROJECT MANAGER

HL PROJECT DIRECTOR


012317-1 PROJECT NUMBER

3/16"=1'-0" SCALE

CL DRAWN BY

SHEET NUMBER

**AB-1**

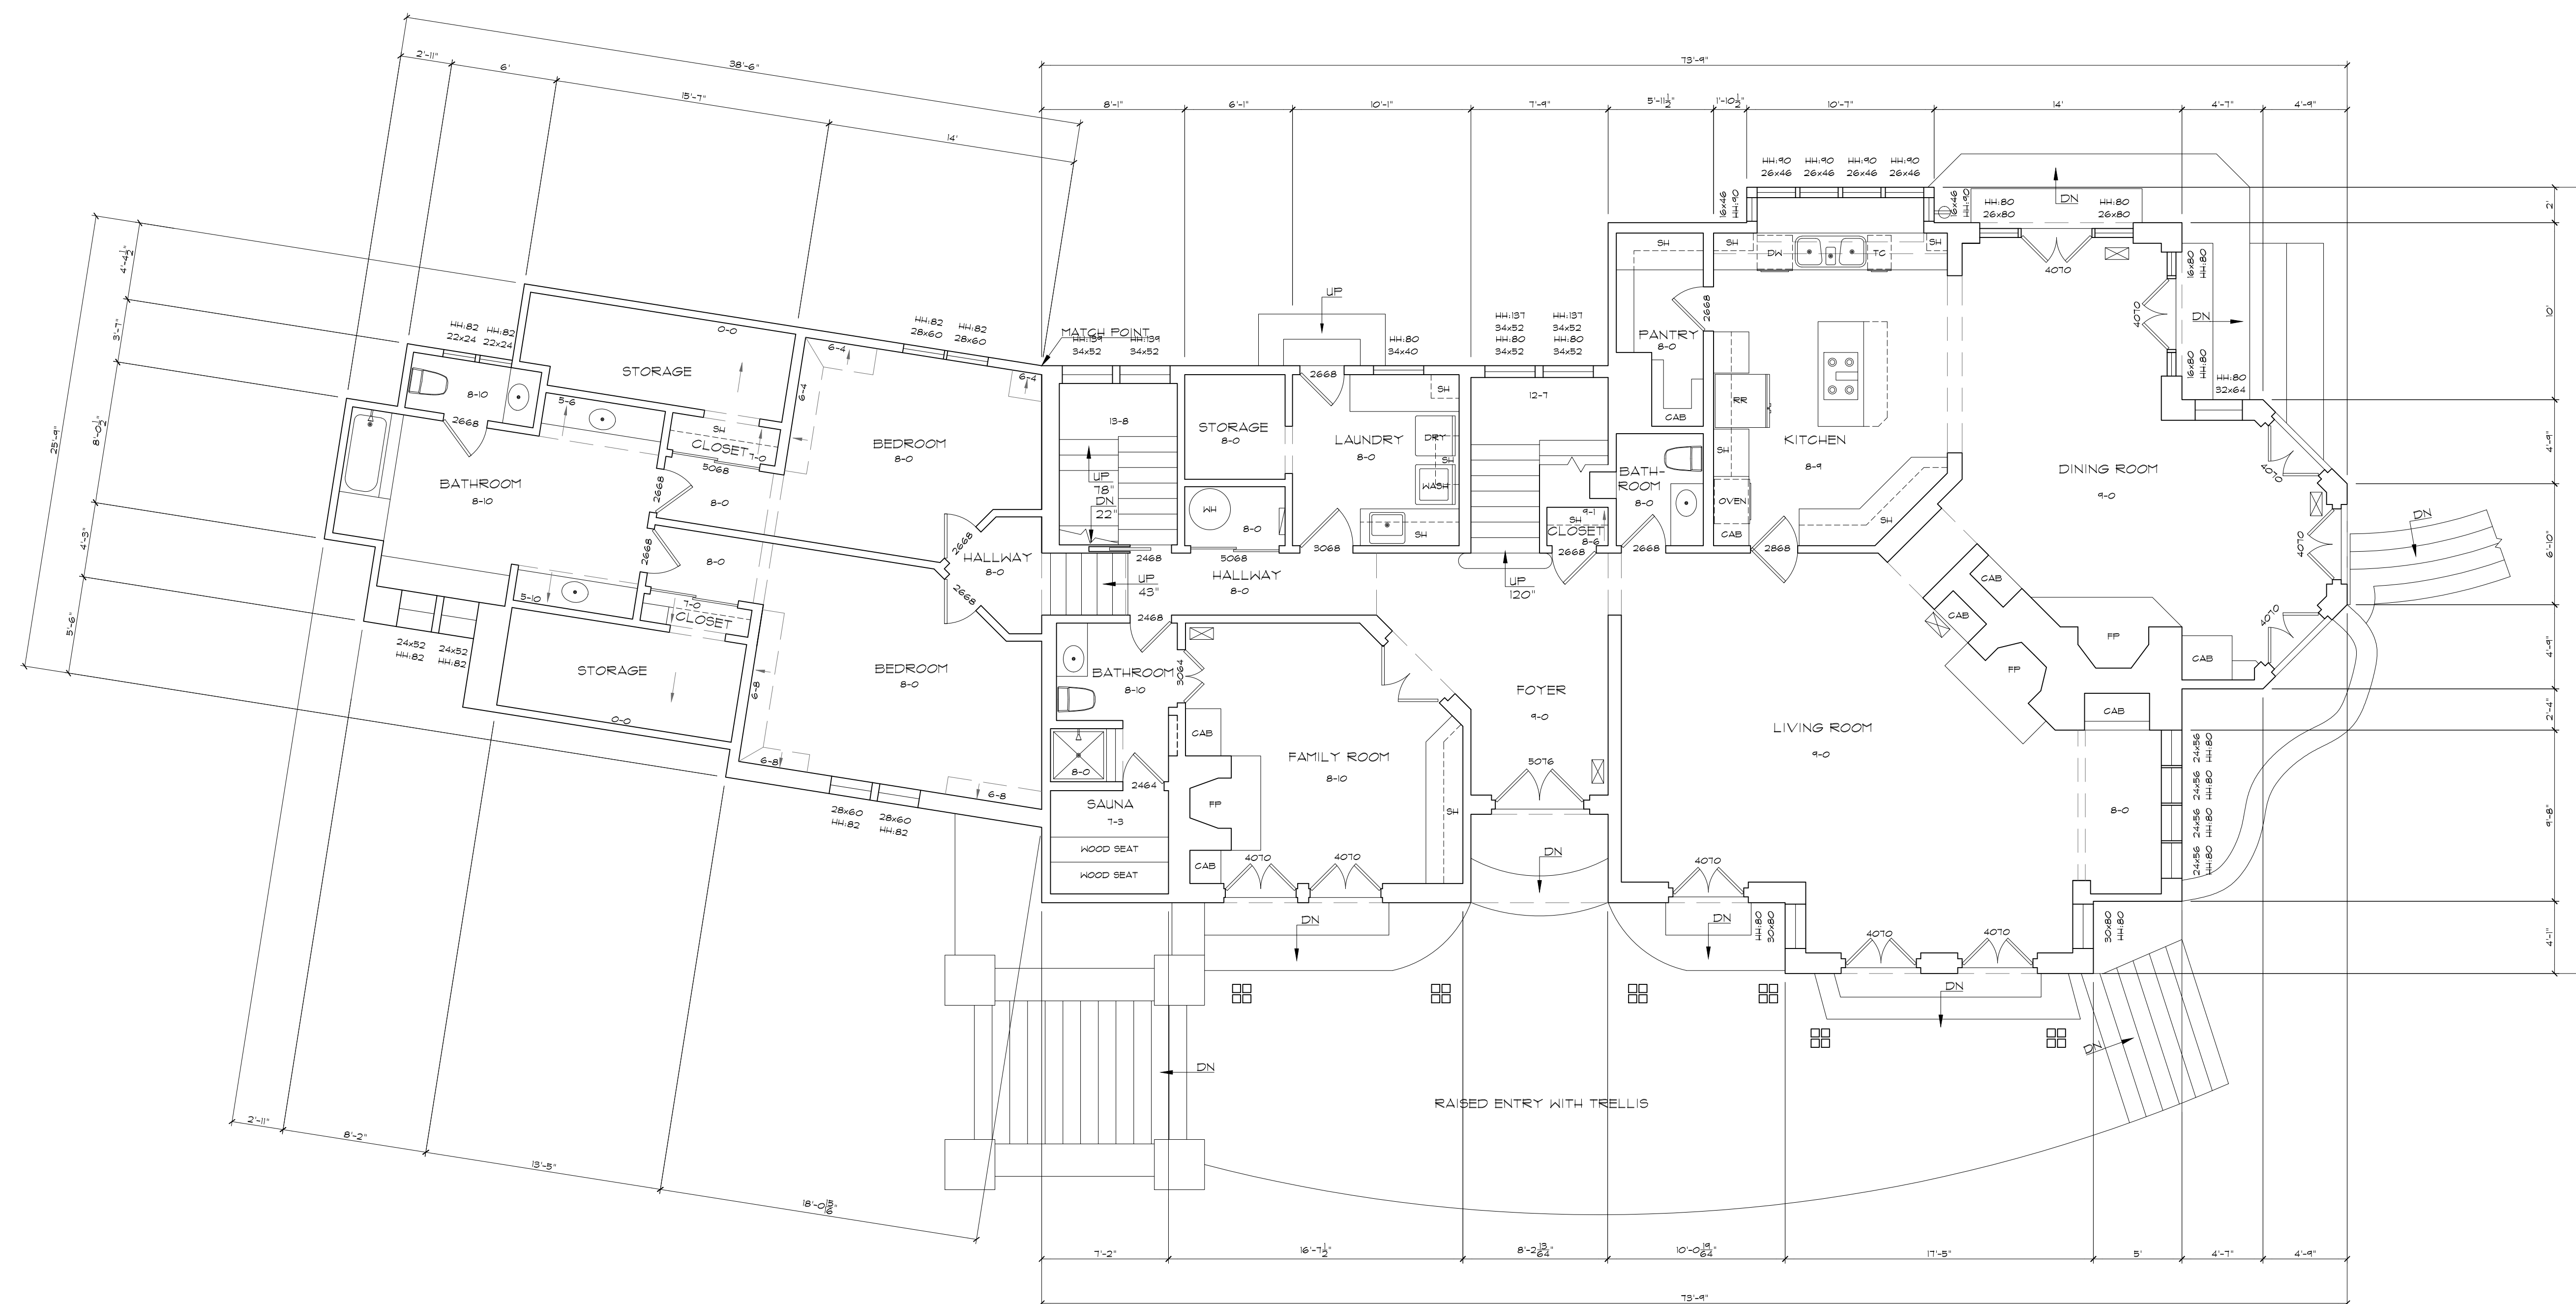

FIRST FLOOR PLAN 3/16"=1'-0"


**ARCHITECTURAL AS BUILT**  
**Saint Helena, CA 94575**

01	100% SUBMISSION	SEE COVER SHEET
NO.	ISSUES   REVISIONS	DATE
		SHEET TITLE

HL	PROJECT MANAGER
HL	PROJECT DIRECTOR
012317-1	PROJECT NUMBER
3/16"=1'-0"	SCALE
CL	DRAWN BY
	SHEET NUMBER

**AB-2**



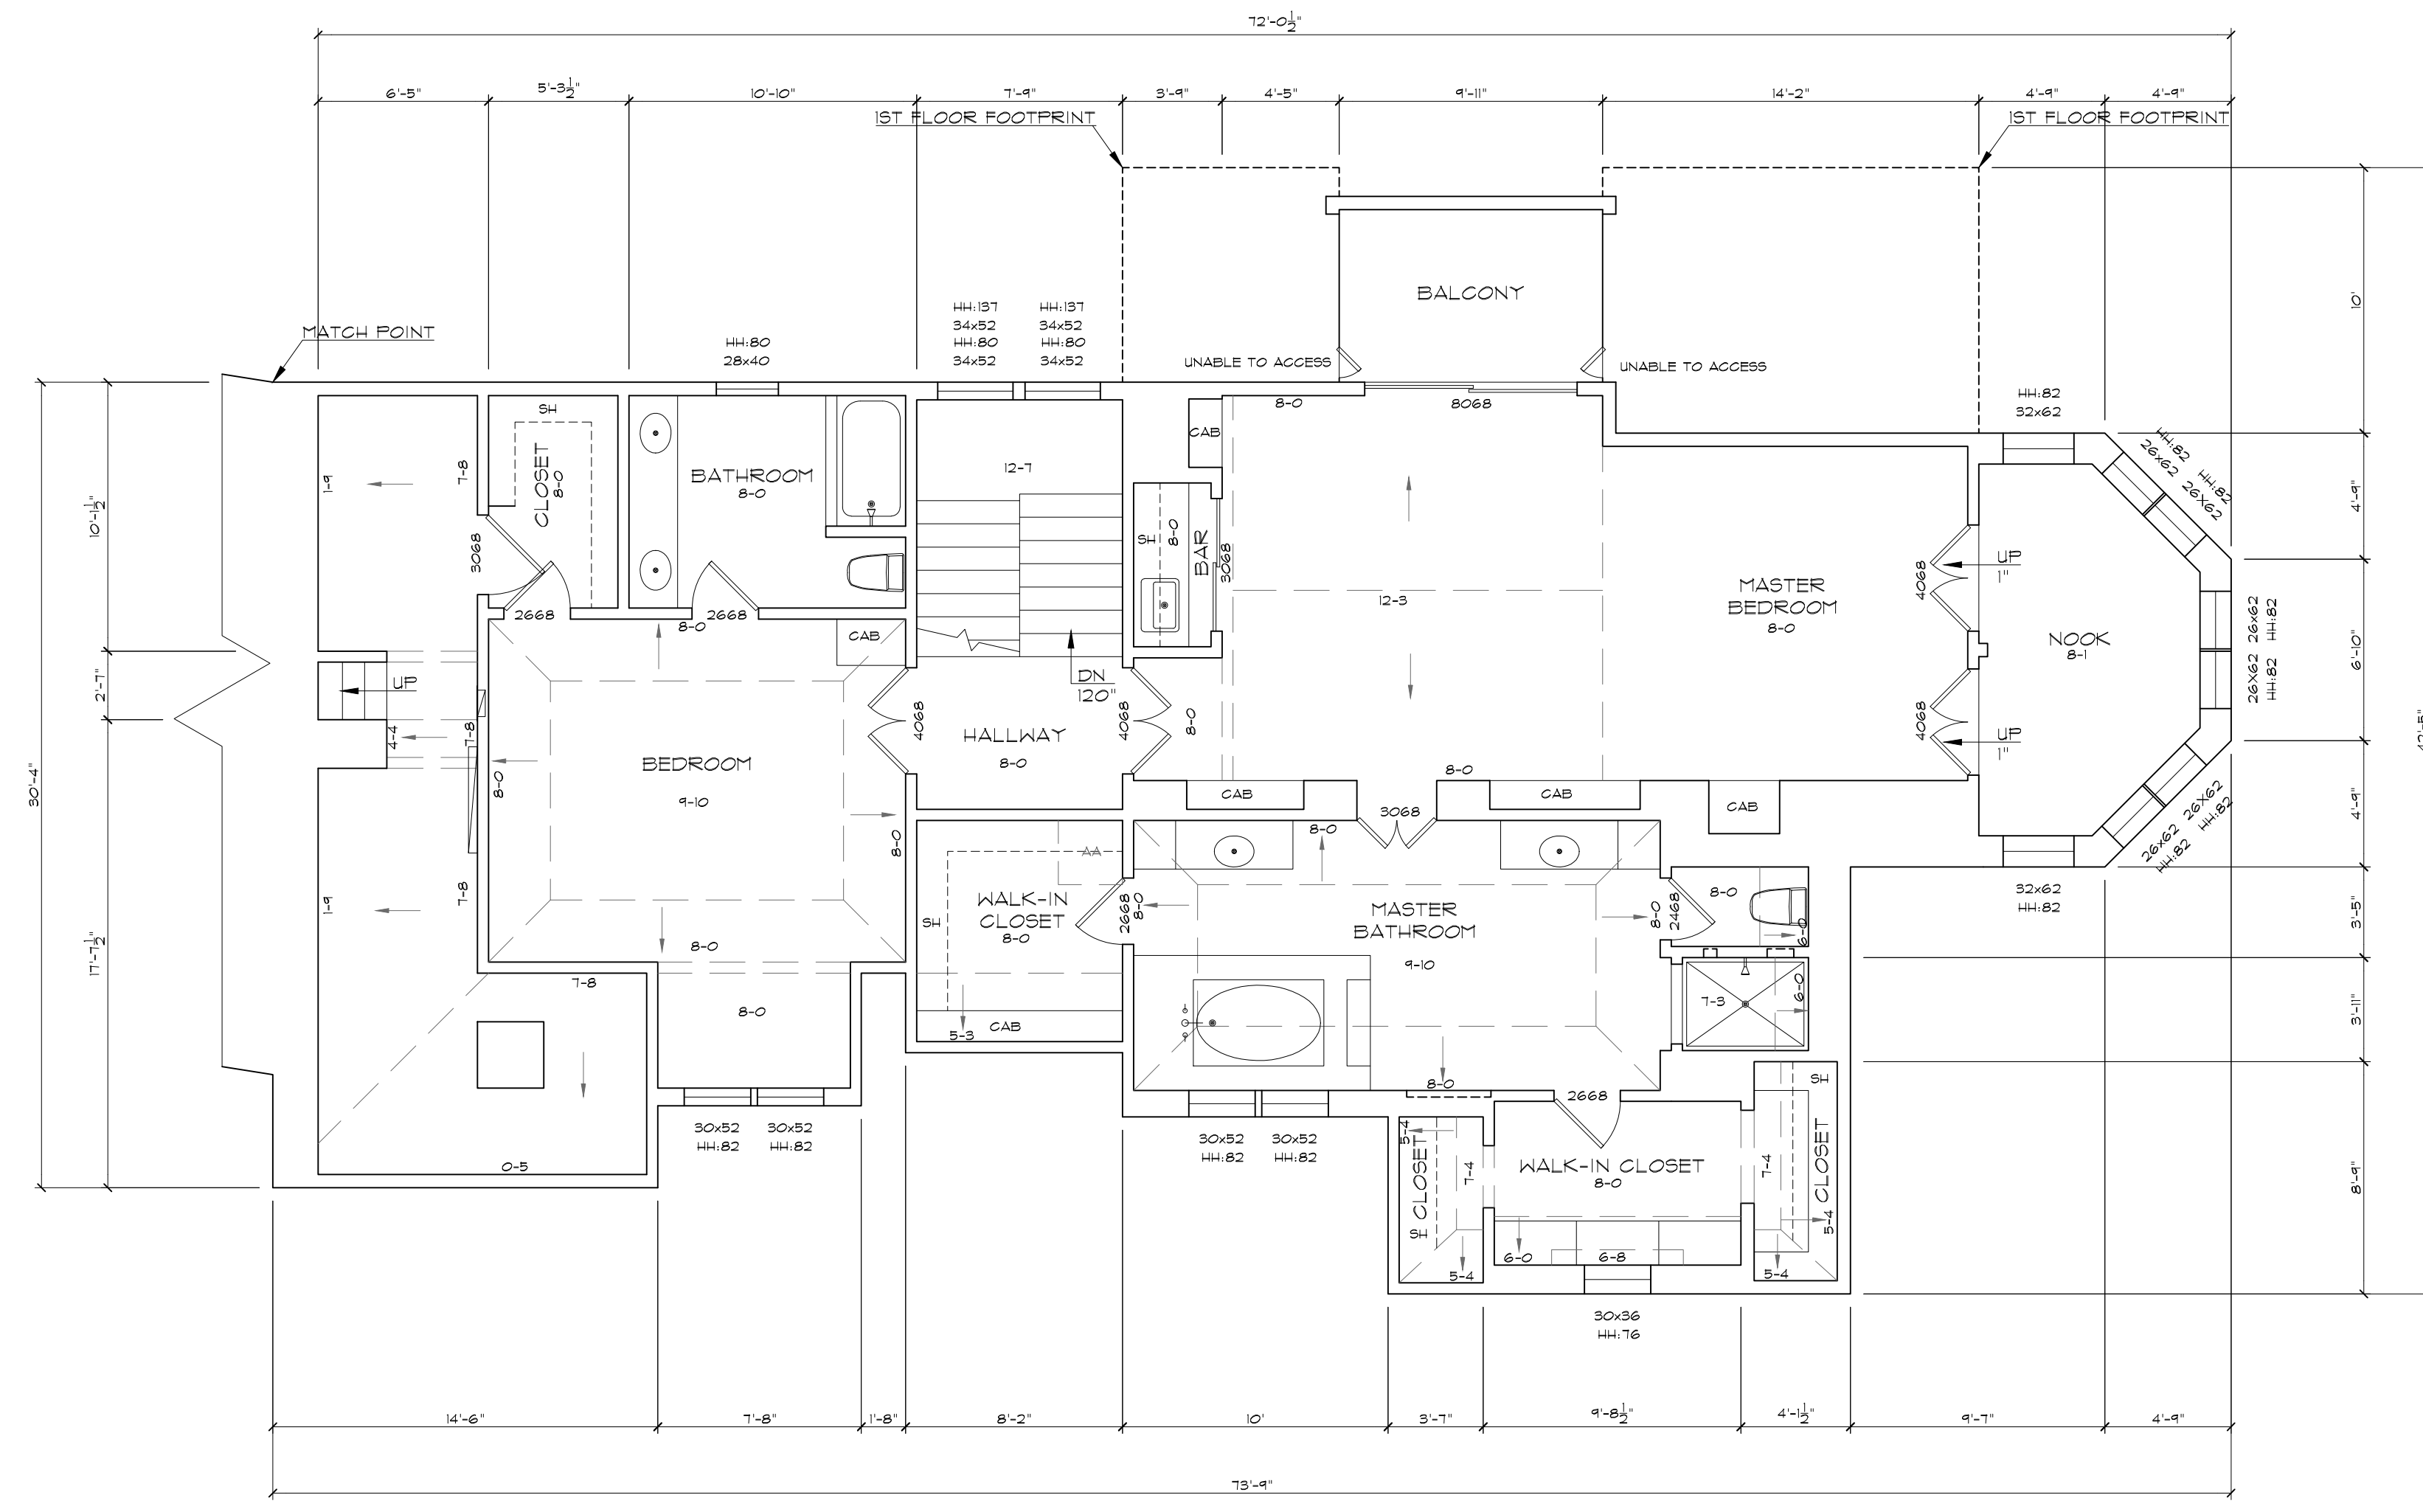

SECOND FLOOR PLAN 3/16"=1'-0"

**ARCHITECTURAL AS BUILT**  
**Saint Helena, CA 94575**

01	100% SUBMISSION	SEE COVER SHEET
NO.	ISSUES   REVISIONS	DATE

HL	PROJECT MANAGER
HL	PROJECT DIRECTOR
012317-1	PROJECT NUMBER
3/16"=1'-0"	SCALE
CL	DRAWN BY
	SHEET NUMBER

**AB-3**