


AS-BUILT DOCUMENTATION

New York, NY 10075

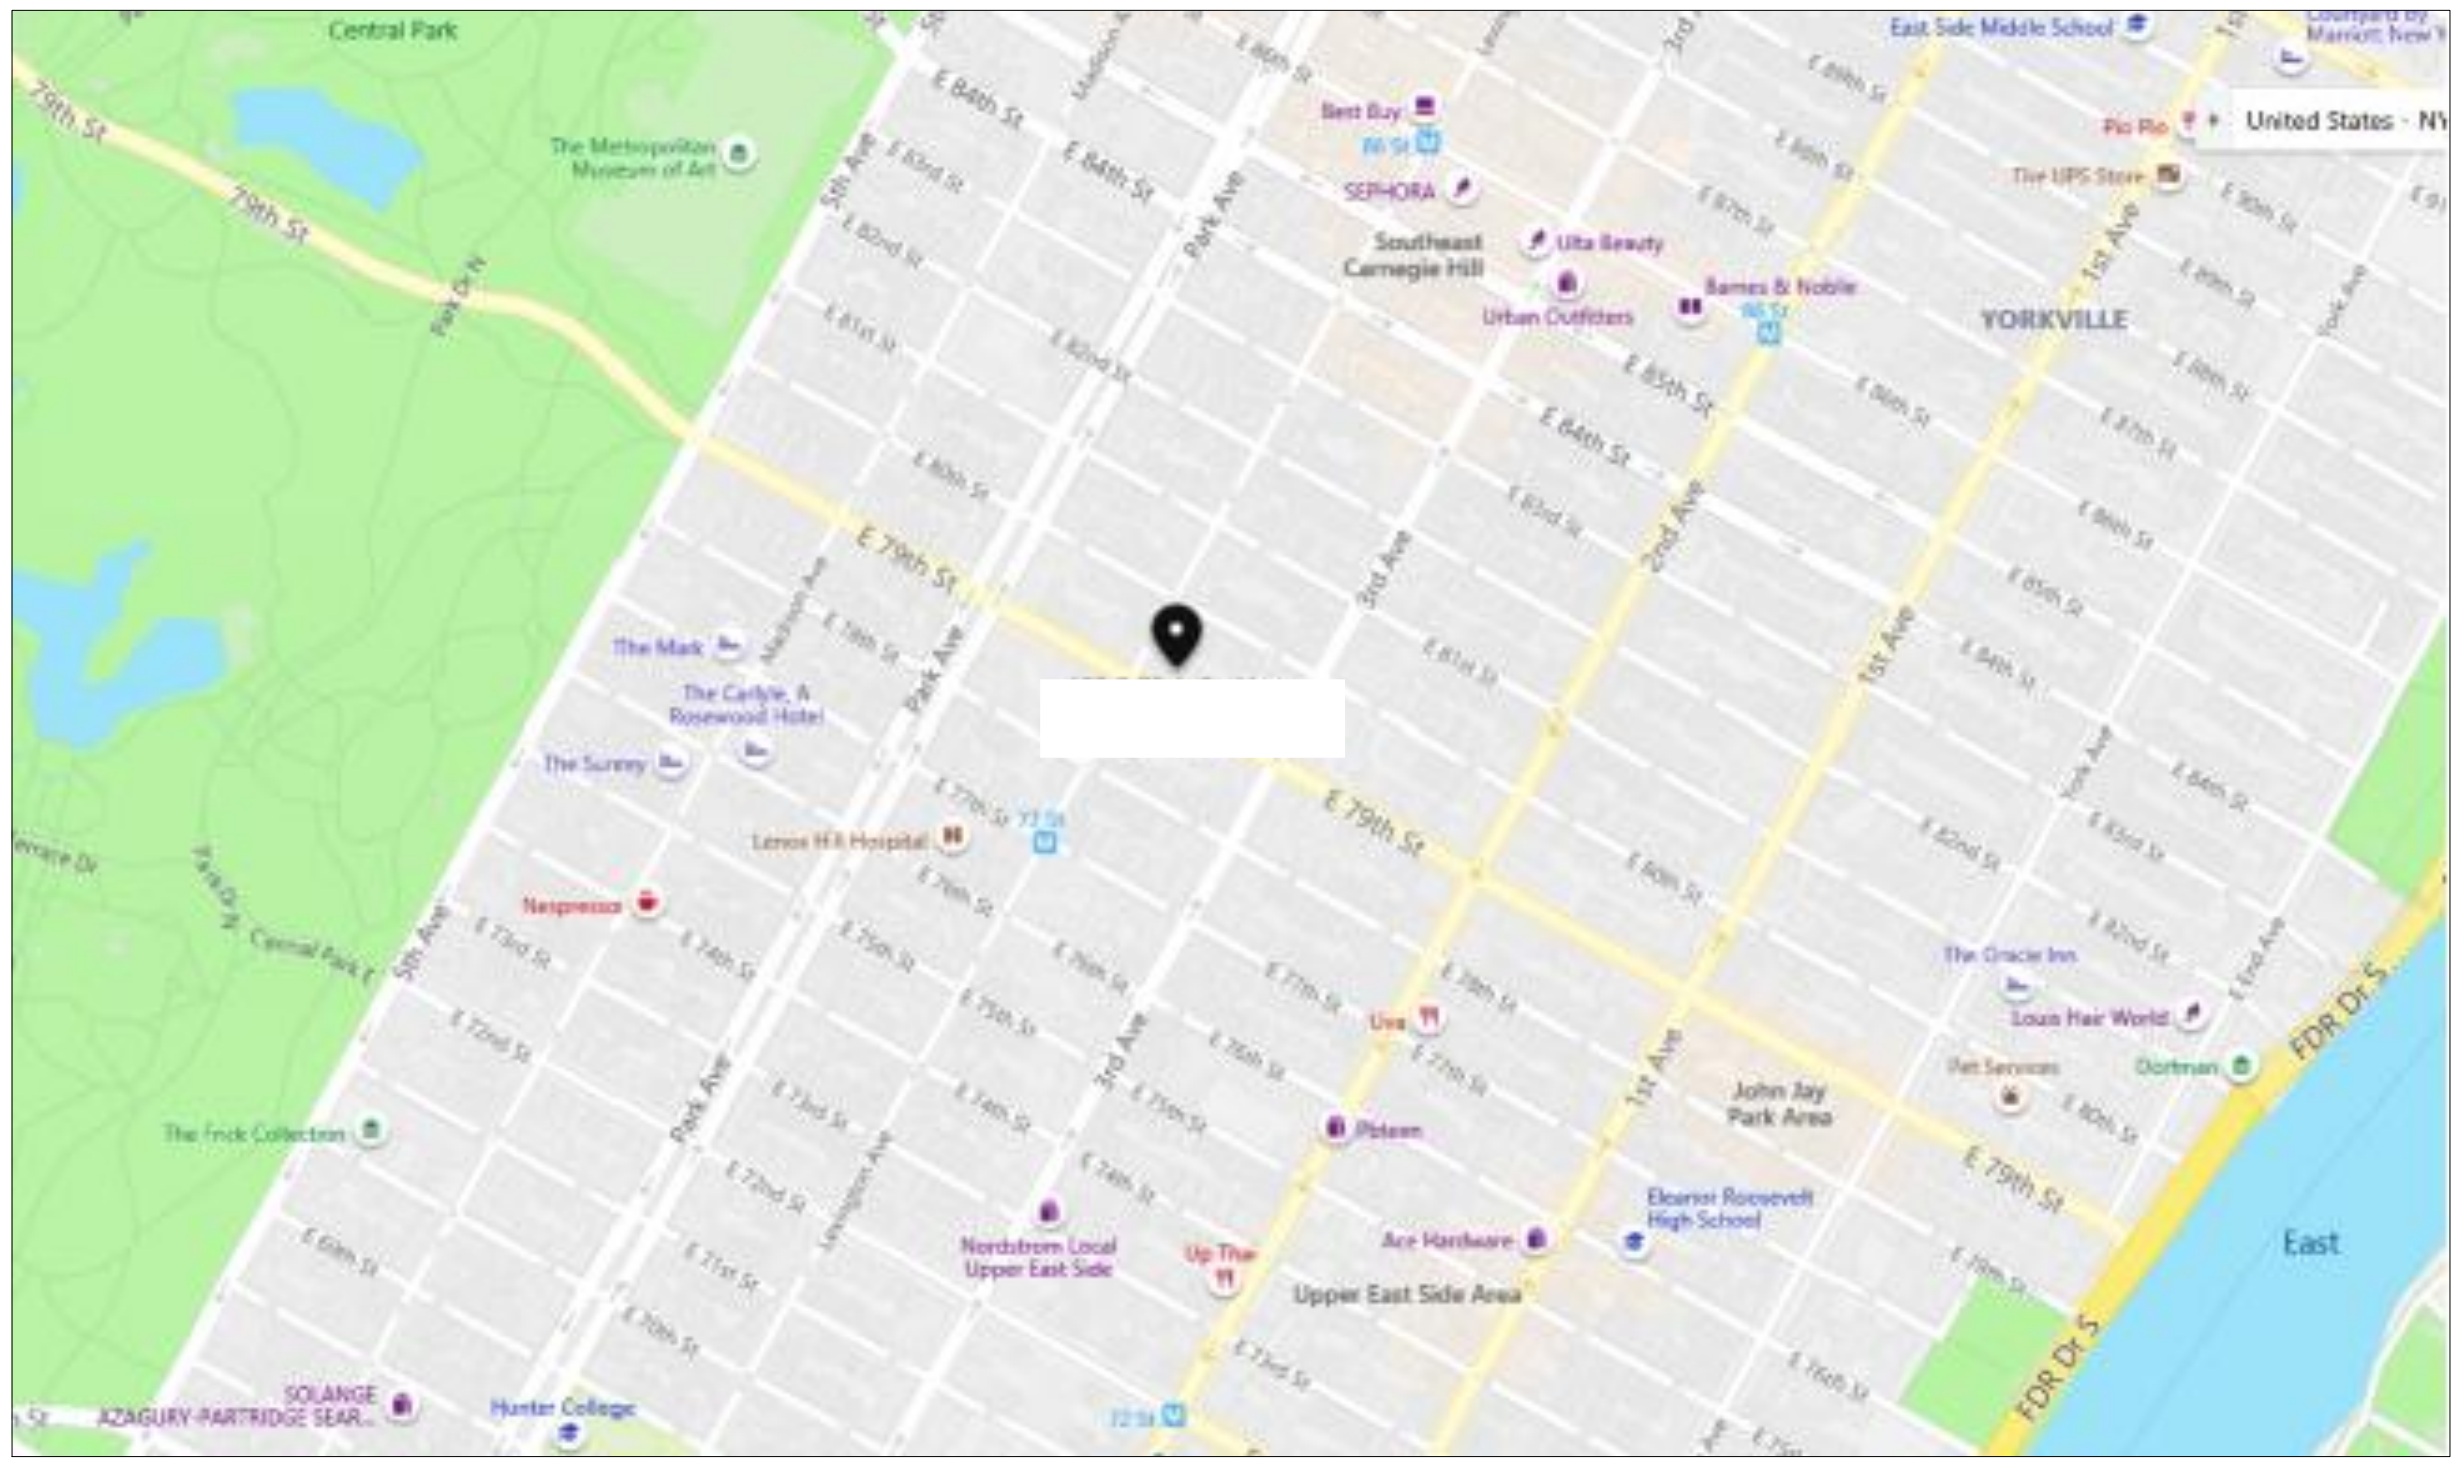

VICINITY MAP
NTS

DRAWING INDEX

- C-1 COVER SHEET | DRAWING INDEX
- SL SYMBOLS LEGEND
- AB-1 11th FLOOR PLAN
- AB-2 12th FLOOR PLAN

AREA DATA	
11th FLOOR	2,191 S.F. ±
TERRACE	110 S.F. ±
COMMON STAIRWELL	162 S.F. ±
12th FLOOR	2,191 S.F. ±
COMMON STAIRWELL	162 S.F. ±
RESIDENCE TOTAL	4,492 S.F. ±
COMMON STAIRWELL TOTAL	324 S.F. ±
TOTAL 11th and 12th	4,816 S.F. ±

100% SUBMITTAL



AS BUILT
PROFESSIONALS
www.asbuiltprofessionals.com

A DIVISION OF:

AEC

CONSULTANTS INC

844.272.8458
844 ASBUILT

©2020 AEC CONSULTANTS INC

ARCHITECTURAL AS-BUILT


 
 
 

 
 
 



 


New York, NY 10075

 
 
 
 
 

 

 
 

01		
NO.	ISSUES REVISIONS	DATE
		SHEET TITLE
		COVER SHEET
HL		PROJECT MANAGER
HL		PROJECT DIRECTOR
012317-1		PROJECT NUMBER
		SCALE
BB		DRAWN BY
		SHEET NUMBER

C-1

SYMBOLS LEGEND


 
 




 
 


 
 

RCP

-  EXHAUST VENT
-  CEILING MOUNTED LIGHT FIXTURE
-  CEILING MOUNTED DIRECTIONAL LIGHT
-  RECESSED CAN LIGHT
-  EYEBALL OR SMALL CAN LIGHT
-  PENDANT LIGHT
-  INDIVIDUAL FLUOR. LAY-IN FIXTURE 4 BULB
-  INDIVIDUAL FLUOR. HANGING FIXTURE 2 BULB
-  INDIVIDUAL FLUOR. FLUSH MOUNT FIXTURE 4 BULB
-  CAMERA
-  MOTION DET.
-  SUPPLY VENT
-  RETURN VENT
-  SPEAKER




 



-  TRACK LIGHT OR VANITY LIGHT
-  WALL-MOUNTED LIGHT FIXTURE
-  EMERGENCY EXIT SIGN
-  EMERGENCY EXIT LIGHT
-  EMERGENCY EXIT LIGHT W/ SIGN
-  LIGHTED STAIR SIGN
-  FLOOD LIGHT
-  PHOTO CELL
-  CEILING FAN
-  CEILING FAN W/ LIGHT KIT
-  JUNCTION BOX

7-2-6 CEILING HEIGHT AND TRIM 7'-2" ABOVE FLOOR BELOW WITH 6" CROWN MOULDING. NOTE: ALL CEILINGS NOT LABELED ARE PLASTER. CEILINGS SHOWN WITH A GRID ARE LAY IN ACOUSTICAL TILE..

 

 

 

ELECTRIC

-  DATA OUTLET
-  TELEPHONE JACK
-  ELECTRIC SWITCH
-  CABLE TELEVISION OUTLET
-  DUPLEX RECEPTACLE OUTLET
-  SPECIAL PURPOSE CONNECTION OR OUTLET
-  QUADRUPLEX RECEPTACLE OUTLET
-  FLOOR DUPLEX RECEPTACLE OUTLET
-  ELECTRIC PANEL
-  ELECTRIC METER
-  BUTTON SWITCH
-  DISCONNECT SWITCH
-  GROUND/FLOOR LIGHT
-  KEY PAD

FIRE PROTECTION

-  FIRE EXTINGUISHER
-  FIRE PULL
-  FIRE ALARM (HORN/SRTOBE)
-  SMOKE DETECTOR
-  SMOKE ALARM SPEAKER
-  SPRINKLER HEAD CEILING MOUNT
-  SPRINKLER HEAD WALL MOUNT

MEP

-  THERMOSTAT
-  FLOOR DRAIN
-  VALVE
-  HOSE BIB
-  WATER SUPPLY
-  SUSPENDED GAS HEATER

MISC

-  BOLLARD
-  SPOT ELEVATION

7-2-6

CEILING HEIGHT AND TRIM 7'-2" ABOVE FLOOR BELOW WITH 6" CROWN MOULDING. NOTE: ALL CEILINGS NOT LABELED ARE PLASTER. CEILINGS SHOWN WITH A GRID ARE LAY IN ACOUSTICAL TILE..








 
 
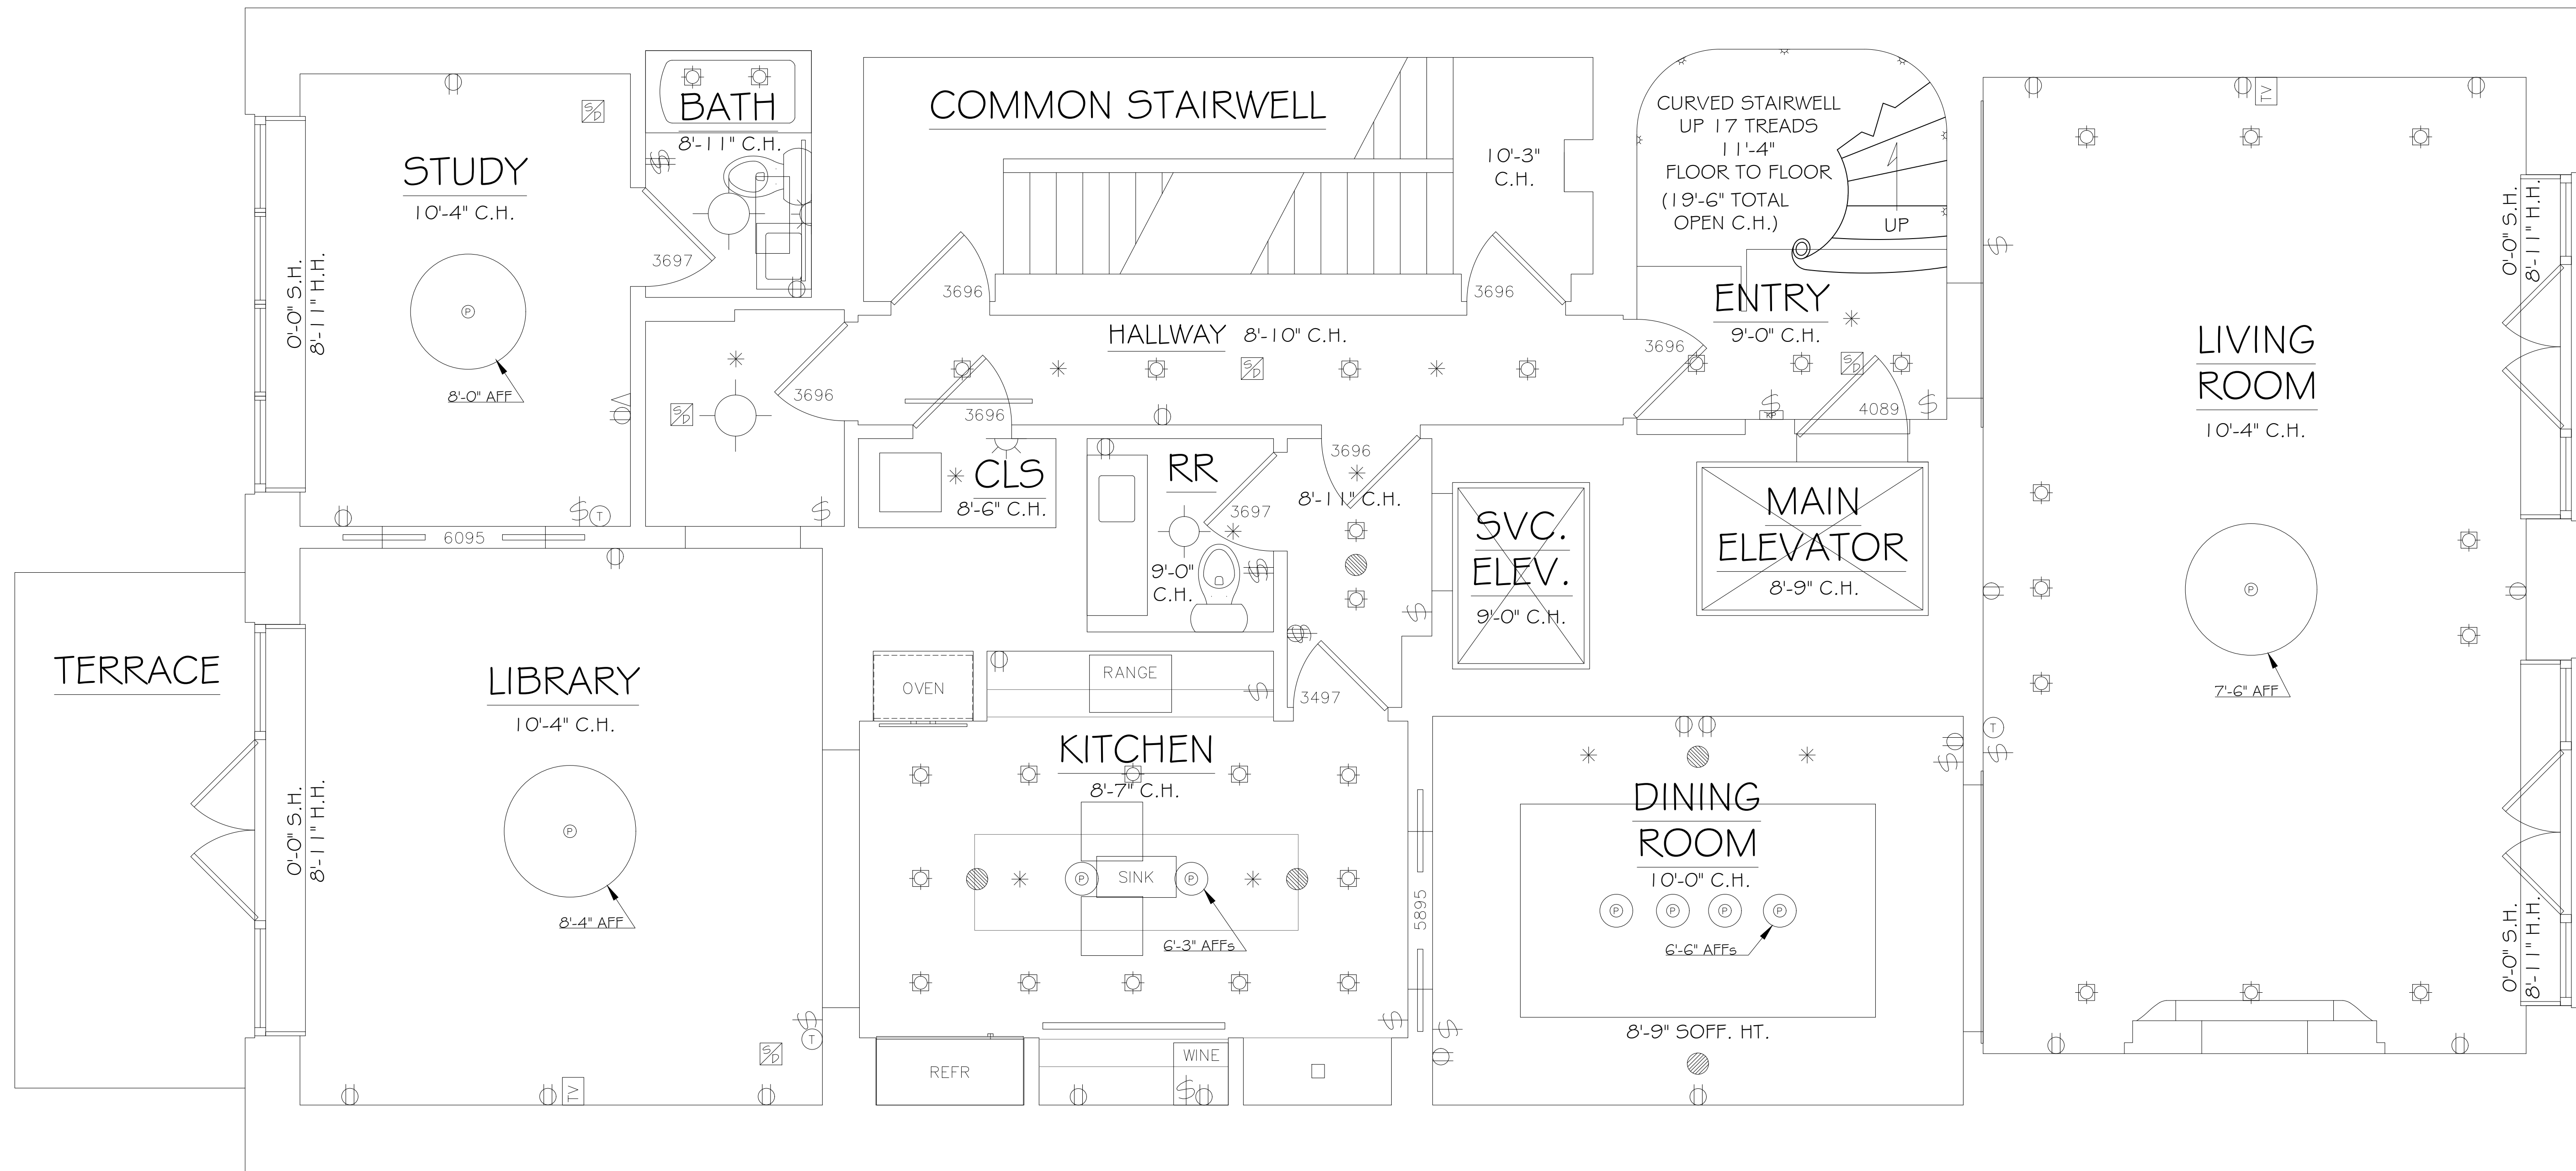


PHOTO DOCUMENTATION LEGEND

-  INDICATES LOCATION OF CAMERA
 -  INDICATES DIRECTION OF CAMERA LENS AND CORRESPONDING PHOTO / VIDEO NUMBER
- TYPES OF DOCUMENTATION**
-  GROUND BASED PHOTO
 -  GROUND BASED VIDEO
 -  360° SPHERICAL PHOTO
 -  AERIAL BASED PHOTO
 -  AERIAL BASED VIDEO

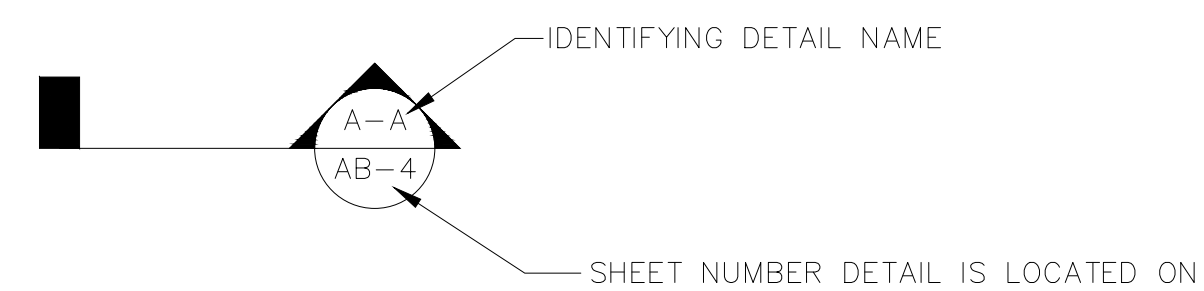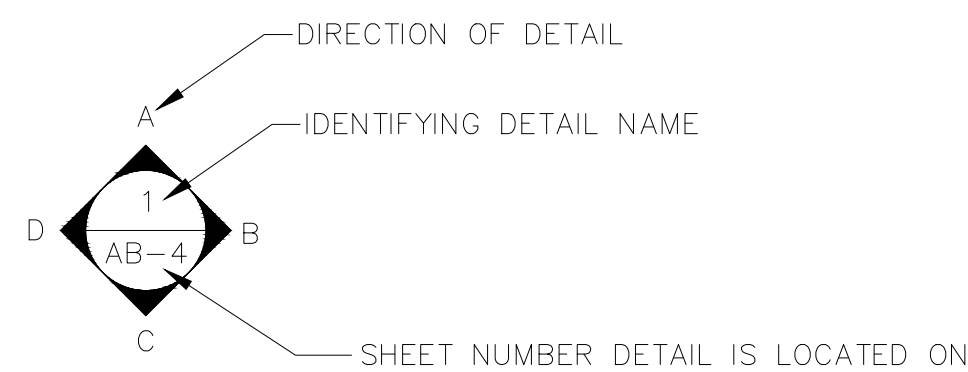01		
NO.	ISSUES REVISIONS	DATE
SHEET TITLE		
HL	PROJECT MANAGER	
HL	PROJECT DIRECTOR	
012317-1	PROJECT NUMBER	
NOT TO SCALE	SCALE	
BB	DRAWN BY	
	SHEET NUMBER	


ARCHITECTURAL AS-BUILT
New York, NY 10075



11th FLOOR PLAN

01		
NO.	ISSUES REVISIONS	DATE
SHEET TITLE		
HL	PROJECT MANAGER	
HL	PROJECT DIRECTOR	
012317-1	PROJECT NUMBER	
3/8"=1'-0"	SCALE	
BB	DRAWN BY	
	SHEET NUMBER	

AB-1

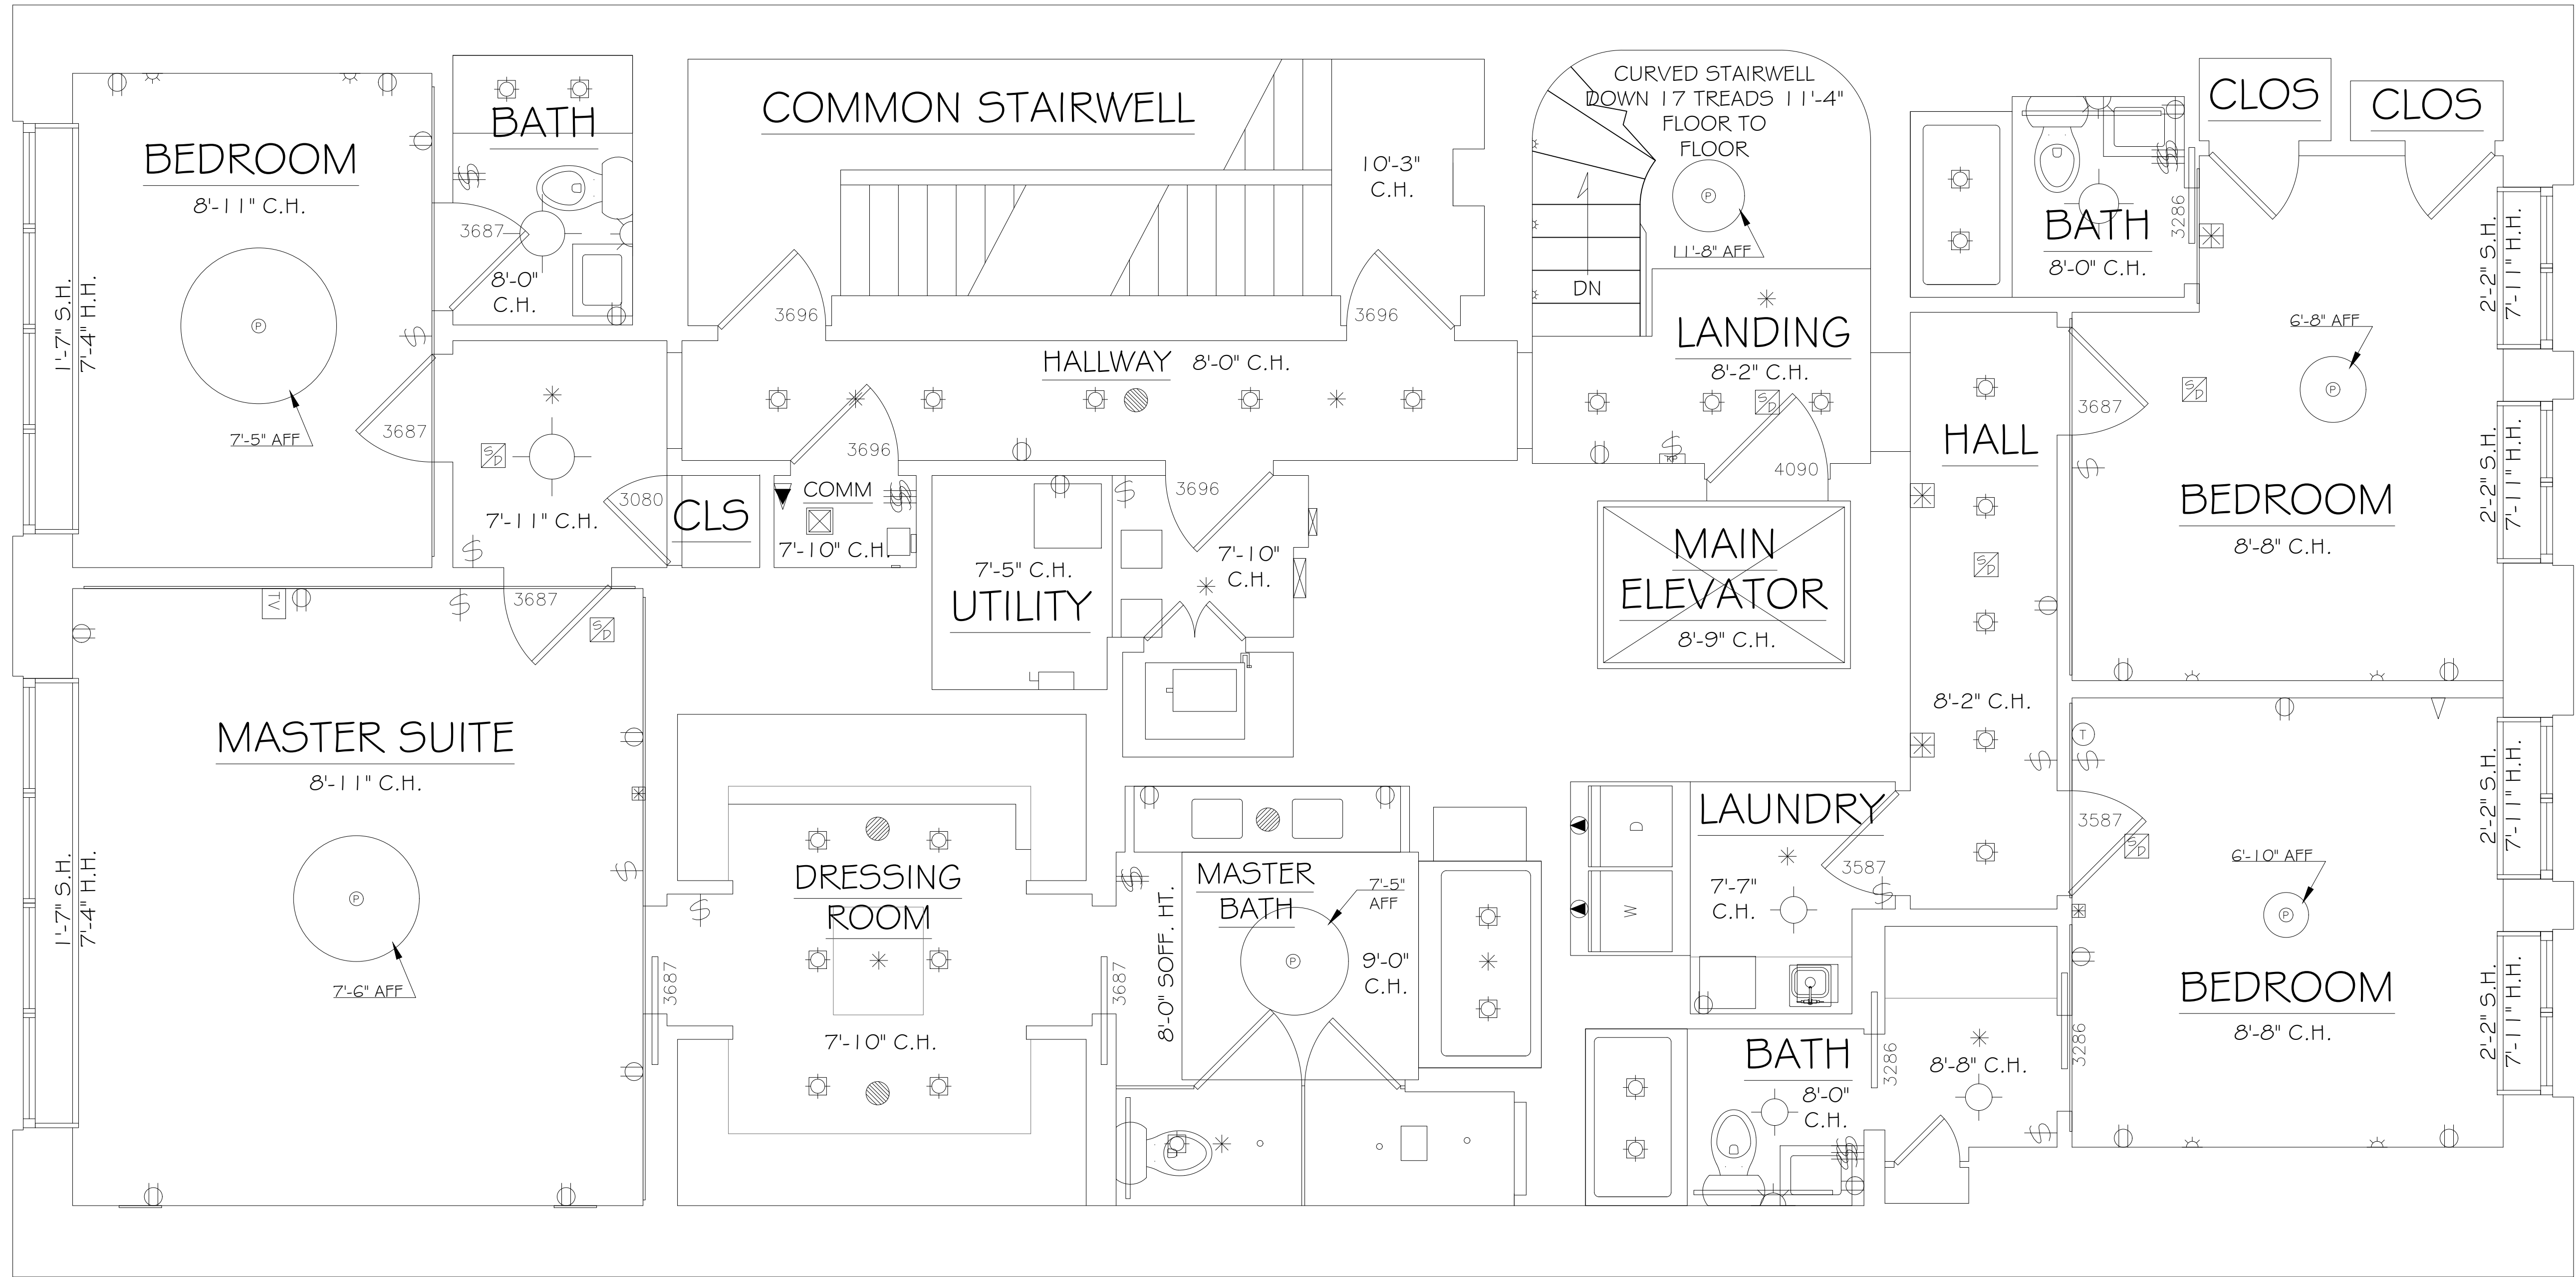

12th FLOOR PLAN

ARCHITECTURAL AS-BUILT
New York, NY 10075

NO.	ISSUES REVISIONS	DATE
01		

HL	PROJECT MANAGER
HL	PROJECT DIRECTOR
012317-1	PROJECT NUMBER
3/8"=1'-0"	SCALE
BB	DRAWN BY
	SHEET NUMBER