

AS-BUILT DOCUMENTATION

SEATTLE, WA 98117



DRAWING INDEX

- C-1 COVER SHEET | DRAWING INDEX
- SL SYMBOLS LEGEND
- AB-1 FIRST FLOOR PLAN AND RCP



© 2020 AEC CONSULTANTS, INC.

ARCHITECTURAL AS BUILT

SEATTLE, WA 98117



VICINITY MAP
NTS

AREA DATA	
FIRST FLOOR	1,317 S.F. ±
GRAND TOTAL	1,317 S.F. ±

100% SUBMITTAL

01	100% SUBMISSION	
NO.	ISSUES REVISIONS	DATE
SHEET TITLE		
COVER SHEET		
HL		PROJECT MANAGER
HL		PROJECT DIRECTOR
?		PROJECT NUMBER
		SCALE
MM		DRAWN BY
		SHEET NUMBER

C-1

SYMBOLS LEGEND

RCP

	EXHAUST VENT		TRACK LIGHT OR VANITY LIGHT
	CEILING MOUNTED LIGHT FIXTURE		WALL-MOUNTED LIGHT FIXTURE
	CEILING MOUNTED DIRECTIONAL LIGHT		EMERGENCY EXIT SIGN
	RECESSED CAN LIGHT		EMERGENCY EXIT LIGHT
	EYEBALL OR SMALL CAN LIGHT		EMERGENCY EXIT LIGHT W/ SIGN
	PENDANT LIGHT		LIGHTED STAIR SIGN
	INDIVIDUAL FLUOR. LAY-IN FIXTURE 4 BULB		FLOOD LIGHT
	INDIVIDUAL FLUOR. HANGING FIXTURE 2 BULB		PHOTO CELL
	INDIVIDUAL FLUOR. FLUSH MOUNT FIXTURE 4 BULB		CEILING FAN
	CAMERA		CEILING FAN W/ LIGHT KIT
	MOTION DET.		7-2-6 CEILING HEIGHT AND TRIM 7'-2" ABOVE FLOOR BELOW WITH 6" CROWN MOULDING. NOTE: ALL CEILINGS NOT LABELED ARE PLASTER. CEILINGS SHOWN WITH A GRID ARE LAY IN ACOUSTICAL TILE..
	SUPPLY VENT		JUNCTION BOX
	SUPPLY VENT		
	RETURN VENT		
	RETURN VENT		
	SPEAKER		

ELECTRIC

	DATA OUTLET
	TELEPHONE JACK
	ELECTRIC SWITCH
	CABLE TELEVISION OUTLET
	DUPLEX RECEPTACLE OUTLET
	SPECIAL PURPOSE CONNECTION OR OUTLET
	QUADRUPLEX RECEPTACLE OUTLET
	FLOOR DUPLEX RECEPTACLE OUTLET
	ELECTRIC PANEL
	ELECTRIC METER
	BUTTON SWITCH
	DISCONNECT SWITCH
	GROUND/FLOOR LIGHT
	KEY PAD

FIRE PROTECTION


	FIRE EXTINGUISHER
	FIRE PULL
	FIRE ALARM (HORN/SRTOBE)
	SMOKE DETECTOR
	SMOKE ALARM SPEAKER
	SPRINKLER HEAD CEILING MOUNT
	SPRINKLER HEAD WALL MOUNT

MEP


	THERMOSTAT
	FLOOR DRAIN
	VALVE
	HOSE BIB
	WATER SUPPLY
	SUSPENDED GAS HEATER

MISC

	BOLLARD
	SPOT ELEVATION

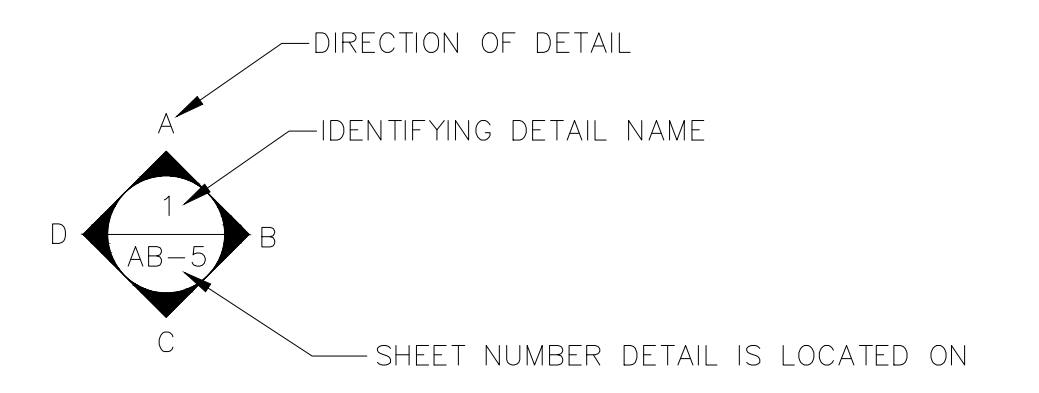


INTERIOR ELEVATIONS

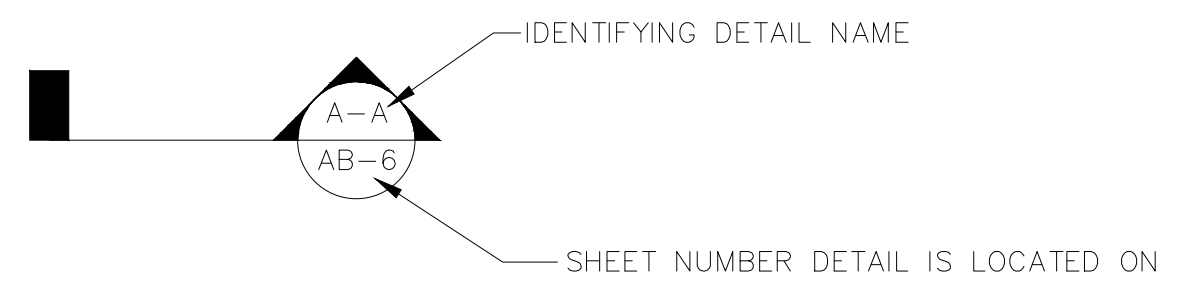

BUILDING SECTION

PHOTO DOCUMENTATION LEGEND

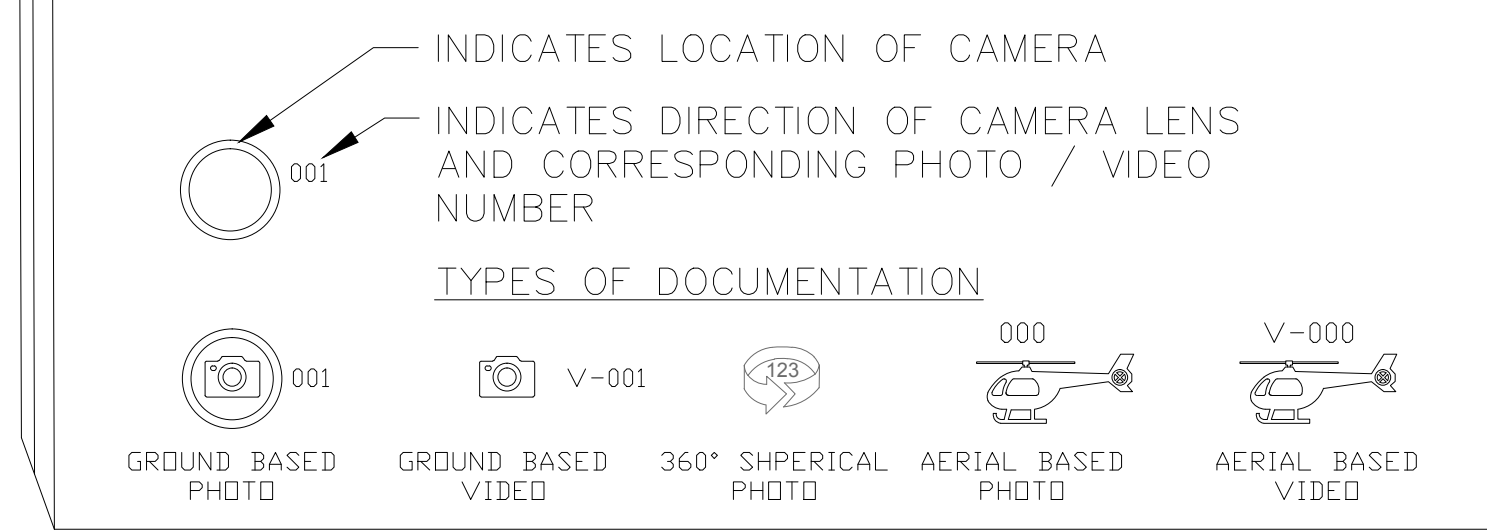


ARCHITECTURAL AS BUILT


SEATTLE, WA 98117

01	100% SUBMISSION	
NL	ISSUES REVISIONS	DATE
		SHEET TITLE
HL		PROJECT MANAGER
HL		PROJECT DIRECTOR
?		PROJECT NUMBER
	NOT TO SCALE	SCALE
MM		DRAWN BY
		SHEET NUMBER

SL

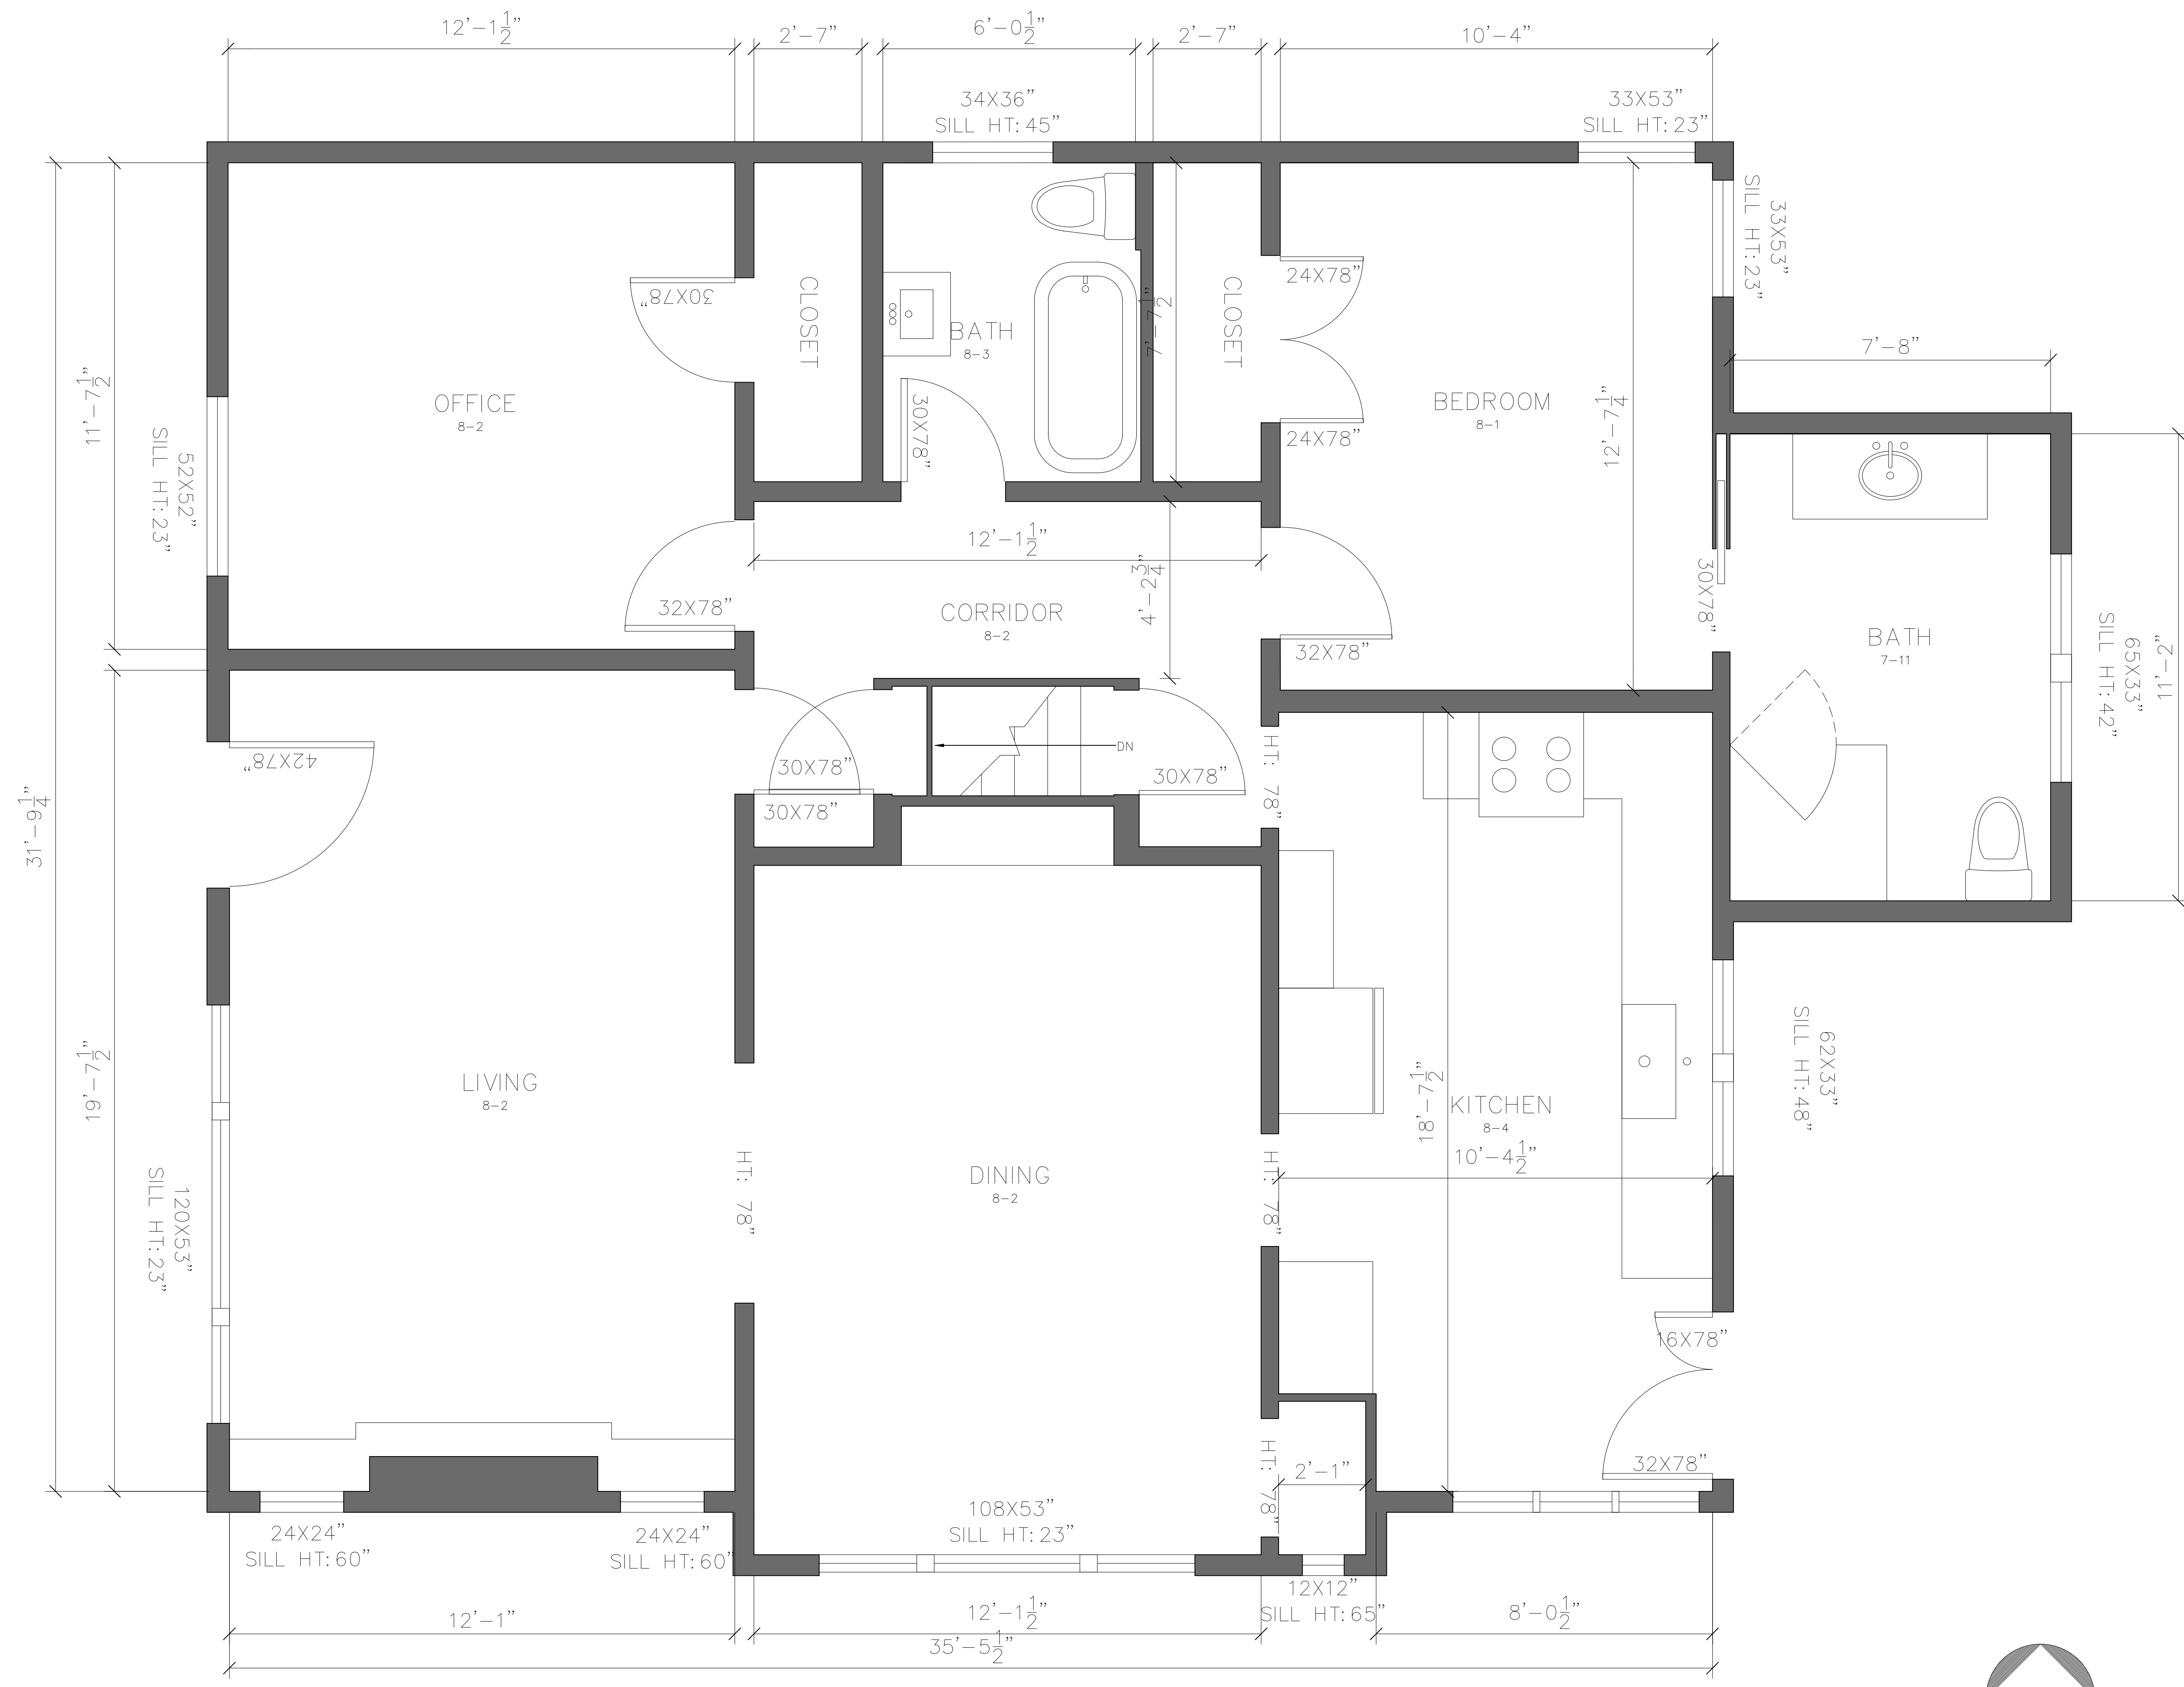

FIRST FLOOR – PLAN

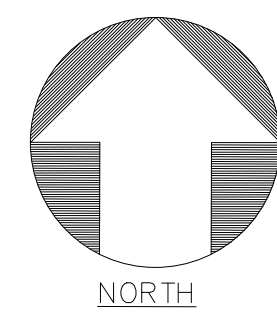

ARCHITECTURAL AS BUILT
SEATTLE, WA 98117

NO.	ISSUES REVISIONS	DATE
01	100% SUBMISSION	

**FIRST FLOOR
PLAN & RCP**

HL	PROJECT MANAGER
HL	PROJECT DIRECTOR
?	PROJECT NUMBER
1/2"=1'-0"	SCALE
MM	DRAWN BY
	SHEET NUMBER