


ATLANTA, GA 30305



100% SUBMITTAL

C-1	COVER SHEET DRAWING INDEX
SL	SYMBOLS LEGEND
AB-1	BASEMENT - DETACHED GARAGE
AB-2	FIRST FLOOR PLAN
AB-3	SECOND FLOOR PLAN
AB-4	EXTERIOR ELEVATIONS
AB-5	EXTERIOR ELEVATIONS
AB-6	EXTERIOR ELEVATIONS

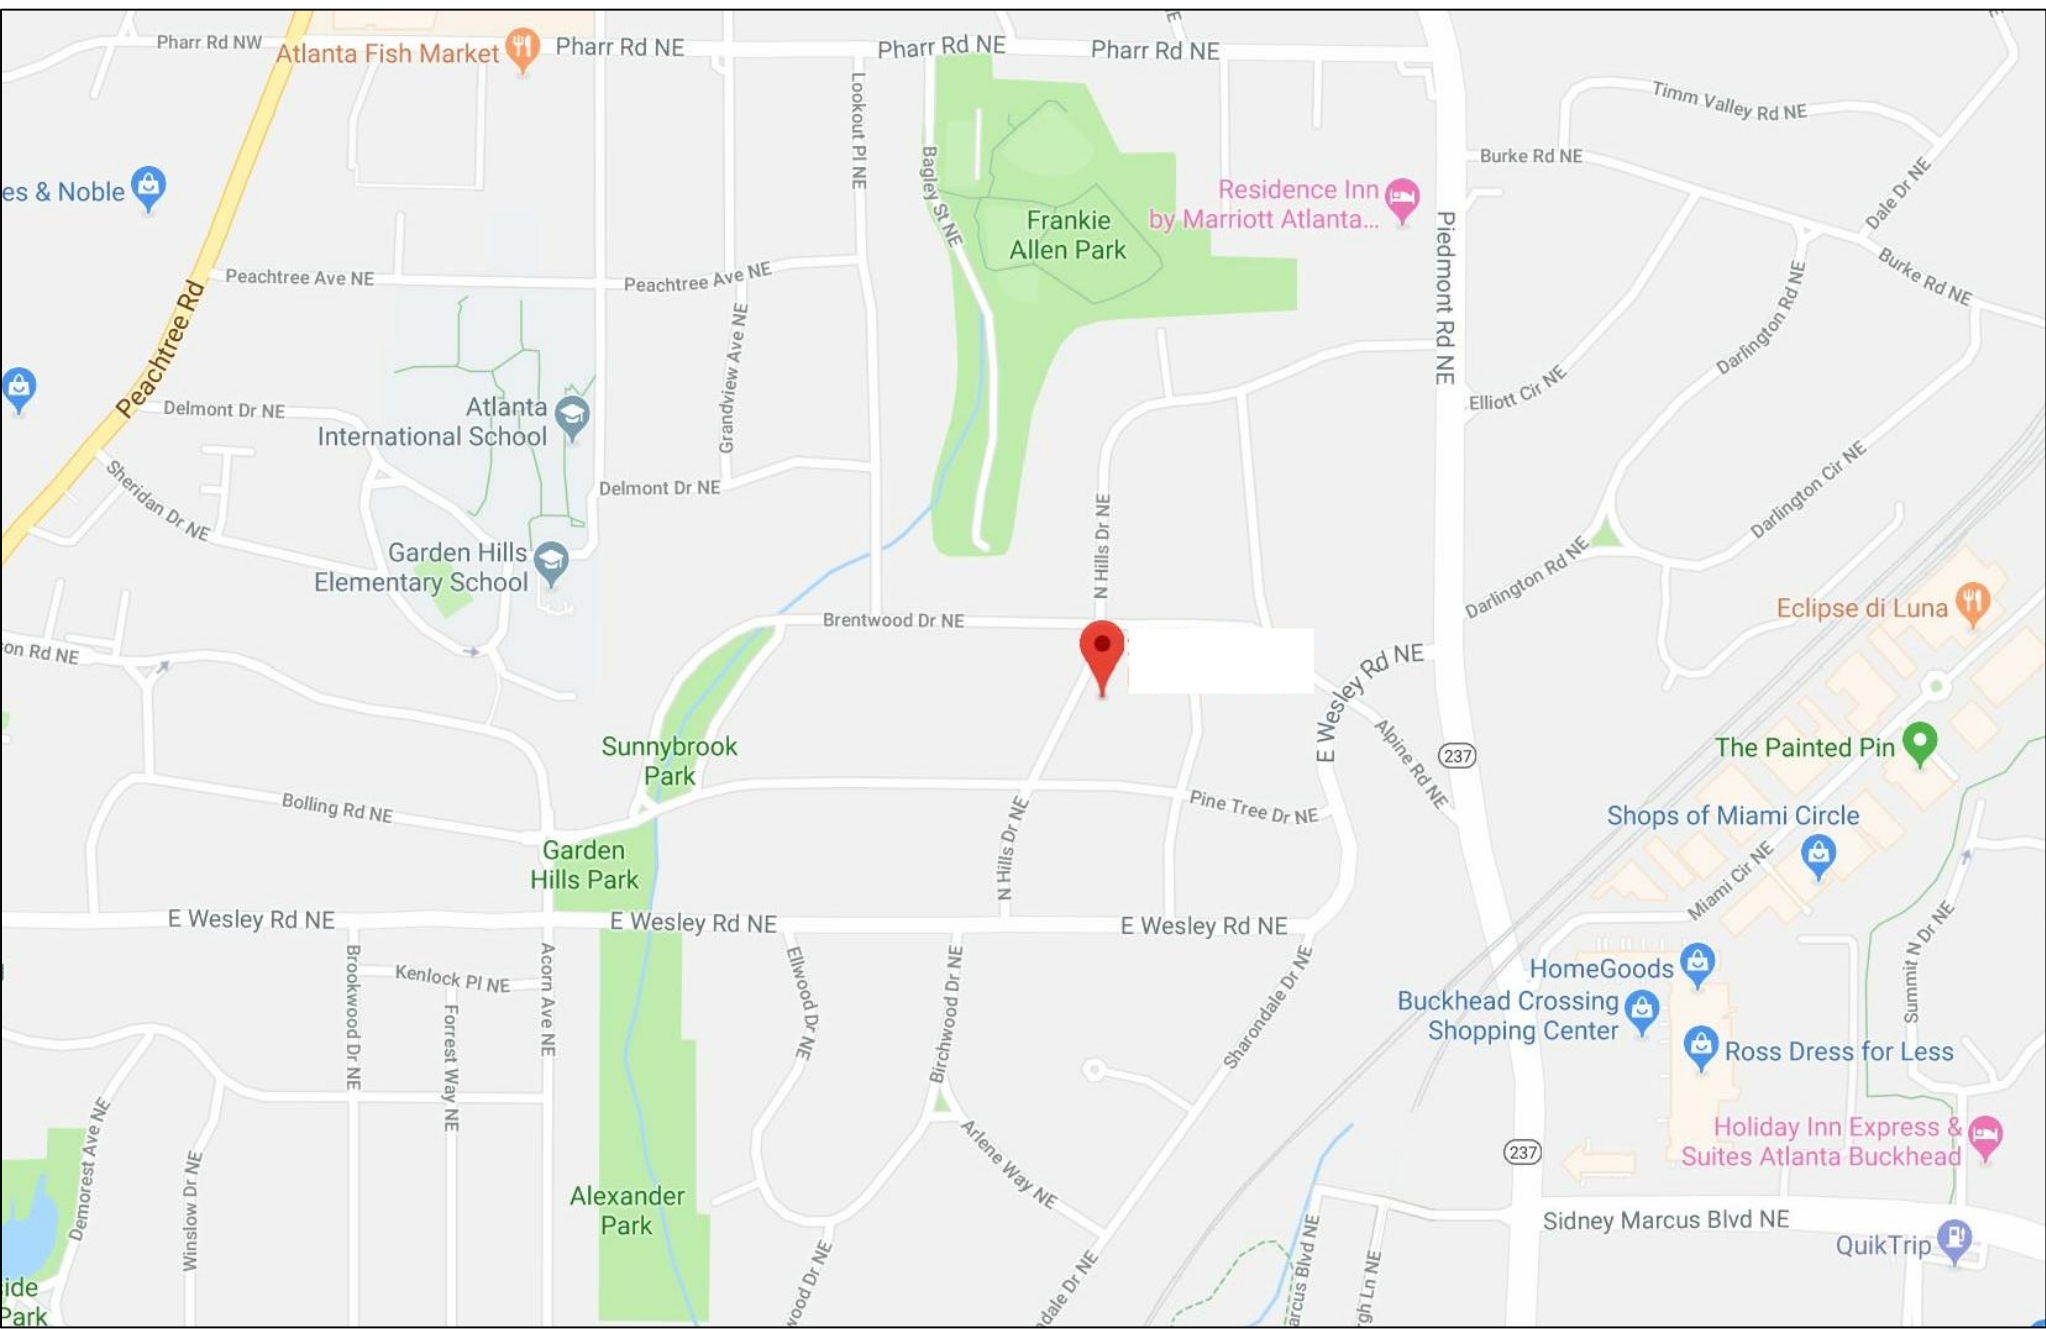

VICINITY MAP

<u>AREA DATA</u>	
BASEMENT	1,837 S.F. ±
FIRST FLOOR TOTAL AREA DOCUMENTED	4,254 S.F. ±
SECOND FLOOR	2,119 S.F. ±
GRAND TOTAL	8,210 S.F. ±

<p>AS BUILT PROFESSIONALS</p> <p>www.asbuiltprofessionals.com</p> <p>A DIVISION OF:</p> <div style="text-align: center;"> <p>AEC CONSULTANTS INC</p> <p>844.272.8458 844 ASBUILT</p> </div> <p>© 2018 AEC CONSULTANTS INC</p>		
<h1 style="margin: 0;">ARCHITECTURAL AS BUILT</h1> <h1 style="margin: 0;">ATLANTA, GA 30305</h1>		
O1	100% SUBMISSION	SEE COVER SHEET
NO.	ISSUES REVISIONS	DATE
		SHEET TITLE
COVER SHEET		
HL	PROJECT MANAGER	
HL	PROJECT DIRECTOR	
012318-1	PROJECT NUMBER	
	SCALE	
CL	DRAWN BY	
	SHEET NUMBER	

SYMBOLS LEGEND

RCP

- EXHAUST VENT
- CEILING MOUNTED LIGHT FIXTURE
- CEILING MOUNTED DIRECTIONAL LIGHT
- RECESSED CAN LIGHT
- EYEBALL OR SMALL CAN LIGHT
- PENDANT LIGHT
- INDIVIDUAL FLUOR. LAY-IN FIXTURE 4 BULB
- INDIVIDUAL FLUOR. HANGING FIXTURE 2 BULB
- INDIVIDUAL FLUOR. FLUSH MOUNT FIXTURE 4 BULB
- CAMERA
- MOTION DET.
- SUPPLY VENT
- SUPPLY VENT
- RETURN VENT
- RETURN VENT
- SPEAKER

- TRACK LIGHT OR VANITY LIGHT
- WALL-MOUNTED LIGHT FIXTURE
- EMERGENCY EXIT SIGN
- EMERGENCY EXIT LIGHT
- EMERGENCY EXIT LIGHT W/ SIGN
- LIGHTED STAIR SIGN
- FLOOD LIGHT
- PHOTO CELL
- CEILING FAN
- CEILING FAN W/ LIGHT KIT
- 7-2-6
- CEILING HEIGHT AND TRIM 7'-2" ABOVE FLOOR BELOW WITH 6" CROWN MOULDING. NOTE: ALL CEILINGS NOT LABELED ARE PLASTER. CEILINGS SHOWN WITH A GRID ARE LAY IN ACOUSTICAL TILE..
- JUNCTION BOX

ELECTRIC

- DATA OUTLET
- TELEPHONE JACK
- ELECTRIC SWITCH
- CABLE TELEVISION OUTLET
- DUPLEX RECEPTACLE OUTLET
- SPECIAL PURPOSE CONNECTION OR OUTLET
- QUADRUPLX RECEPTACLE OUTLET
- FLOOR DUPLEX RECEPTACLE OUTLET
- ELECTRIC PANEL
- ELECTRIC METER
- BUTTON SWITCH
- DISCONNECT SWITCH
- GROUND/FLOOR LIGHT
- KEY PAD

FIRE PROTECTION

- FIRE EXTINGUISHER
- FIRE PULL
- FIRE ALARM (HORN/SRTOBE)
- SMOKE DETECTOR
- SMOKE ALARM SPEAKER
- SPRINKLER HEAD CEILING MOUNT
- SPRINKLER HEAD WALL MOUNT

MEP

- THERMOSTAT
- FLOOR DRAIN
- VALVE
- HOSE BIB
- WATER SUPPLY
- SUSPENDED GAS HEATER

MISC

- BOLLARD
- SPOT ELEVATION

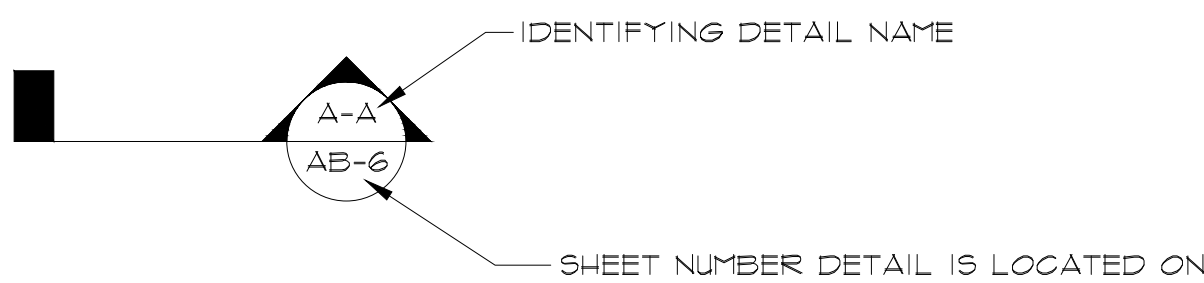
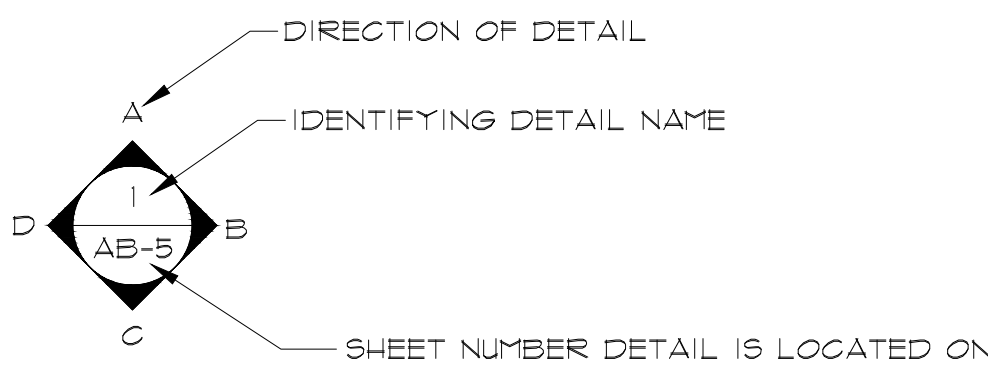


PHOTO DOCUMENTATION LEGEND

INDICATES LOCATION OF CAMERA

INDICATES DIRECTION OF CAMERA LENS AND CORRESPONDING PHOTO / VIDEO NUMBER

TYPES OF DOCUMENTATION

- GROUND BASED PHOTO
- GROUND BASED VIDEO
- 360° SPHERICAL PHOTO
- AERIAL BASED PHOTO
- AERIAL BASED VIDEO

As BUILT
PROFESSIONALS
www.asbuiltprofessionals.com
A DIVISION OF:

AEC
CONSULTANTS
INC
844.272.8458
844 ASBUILT

© 2018 AEC CONSULTANTS INC.

ARCHITECTURAL AS BUILT

ATLANTA, GA 30305

01	100% SUBMISSION	SEE COVER SHEET
NO.	ISSUES REVISIONS	DATE
		SHEET TITLE
HL		PROJECT MANAGER
HL		PROJECT DIRECTOR
012318-1		PROJECT NUMBER
NO SCALE		SCALE
CL		DRAWN BY
		SHEET NUMBER

SL




ARCHITECTURAL AS BUILT

ATLANTA, GA 30305

D01	100% SUBMISSION	SEE COVER SHEET
N0.	ISSUES REVISIONS	DATE
		SHEET TITLE
HL		PROJECT MANAGER
HL		PROJECT DIRECTOR
D012318-1		PROJECT NUMBER
1'4"=1'-0"		SCALE
CL		DRAWN BY
		SHEET NUMBER

AB-1

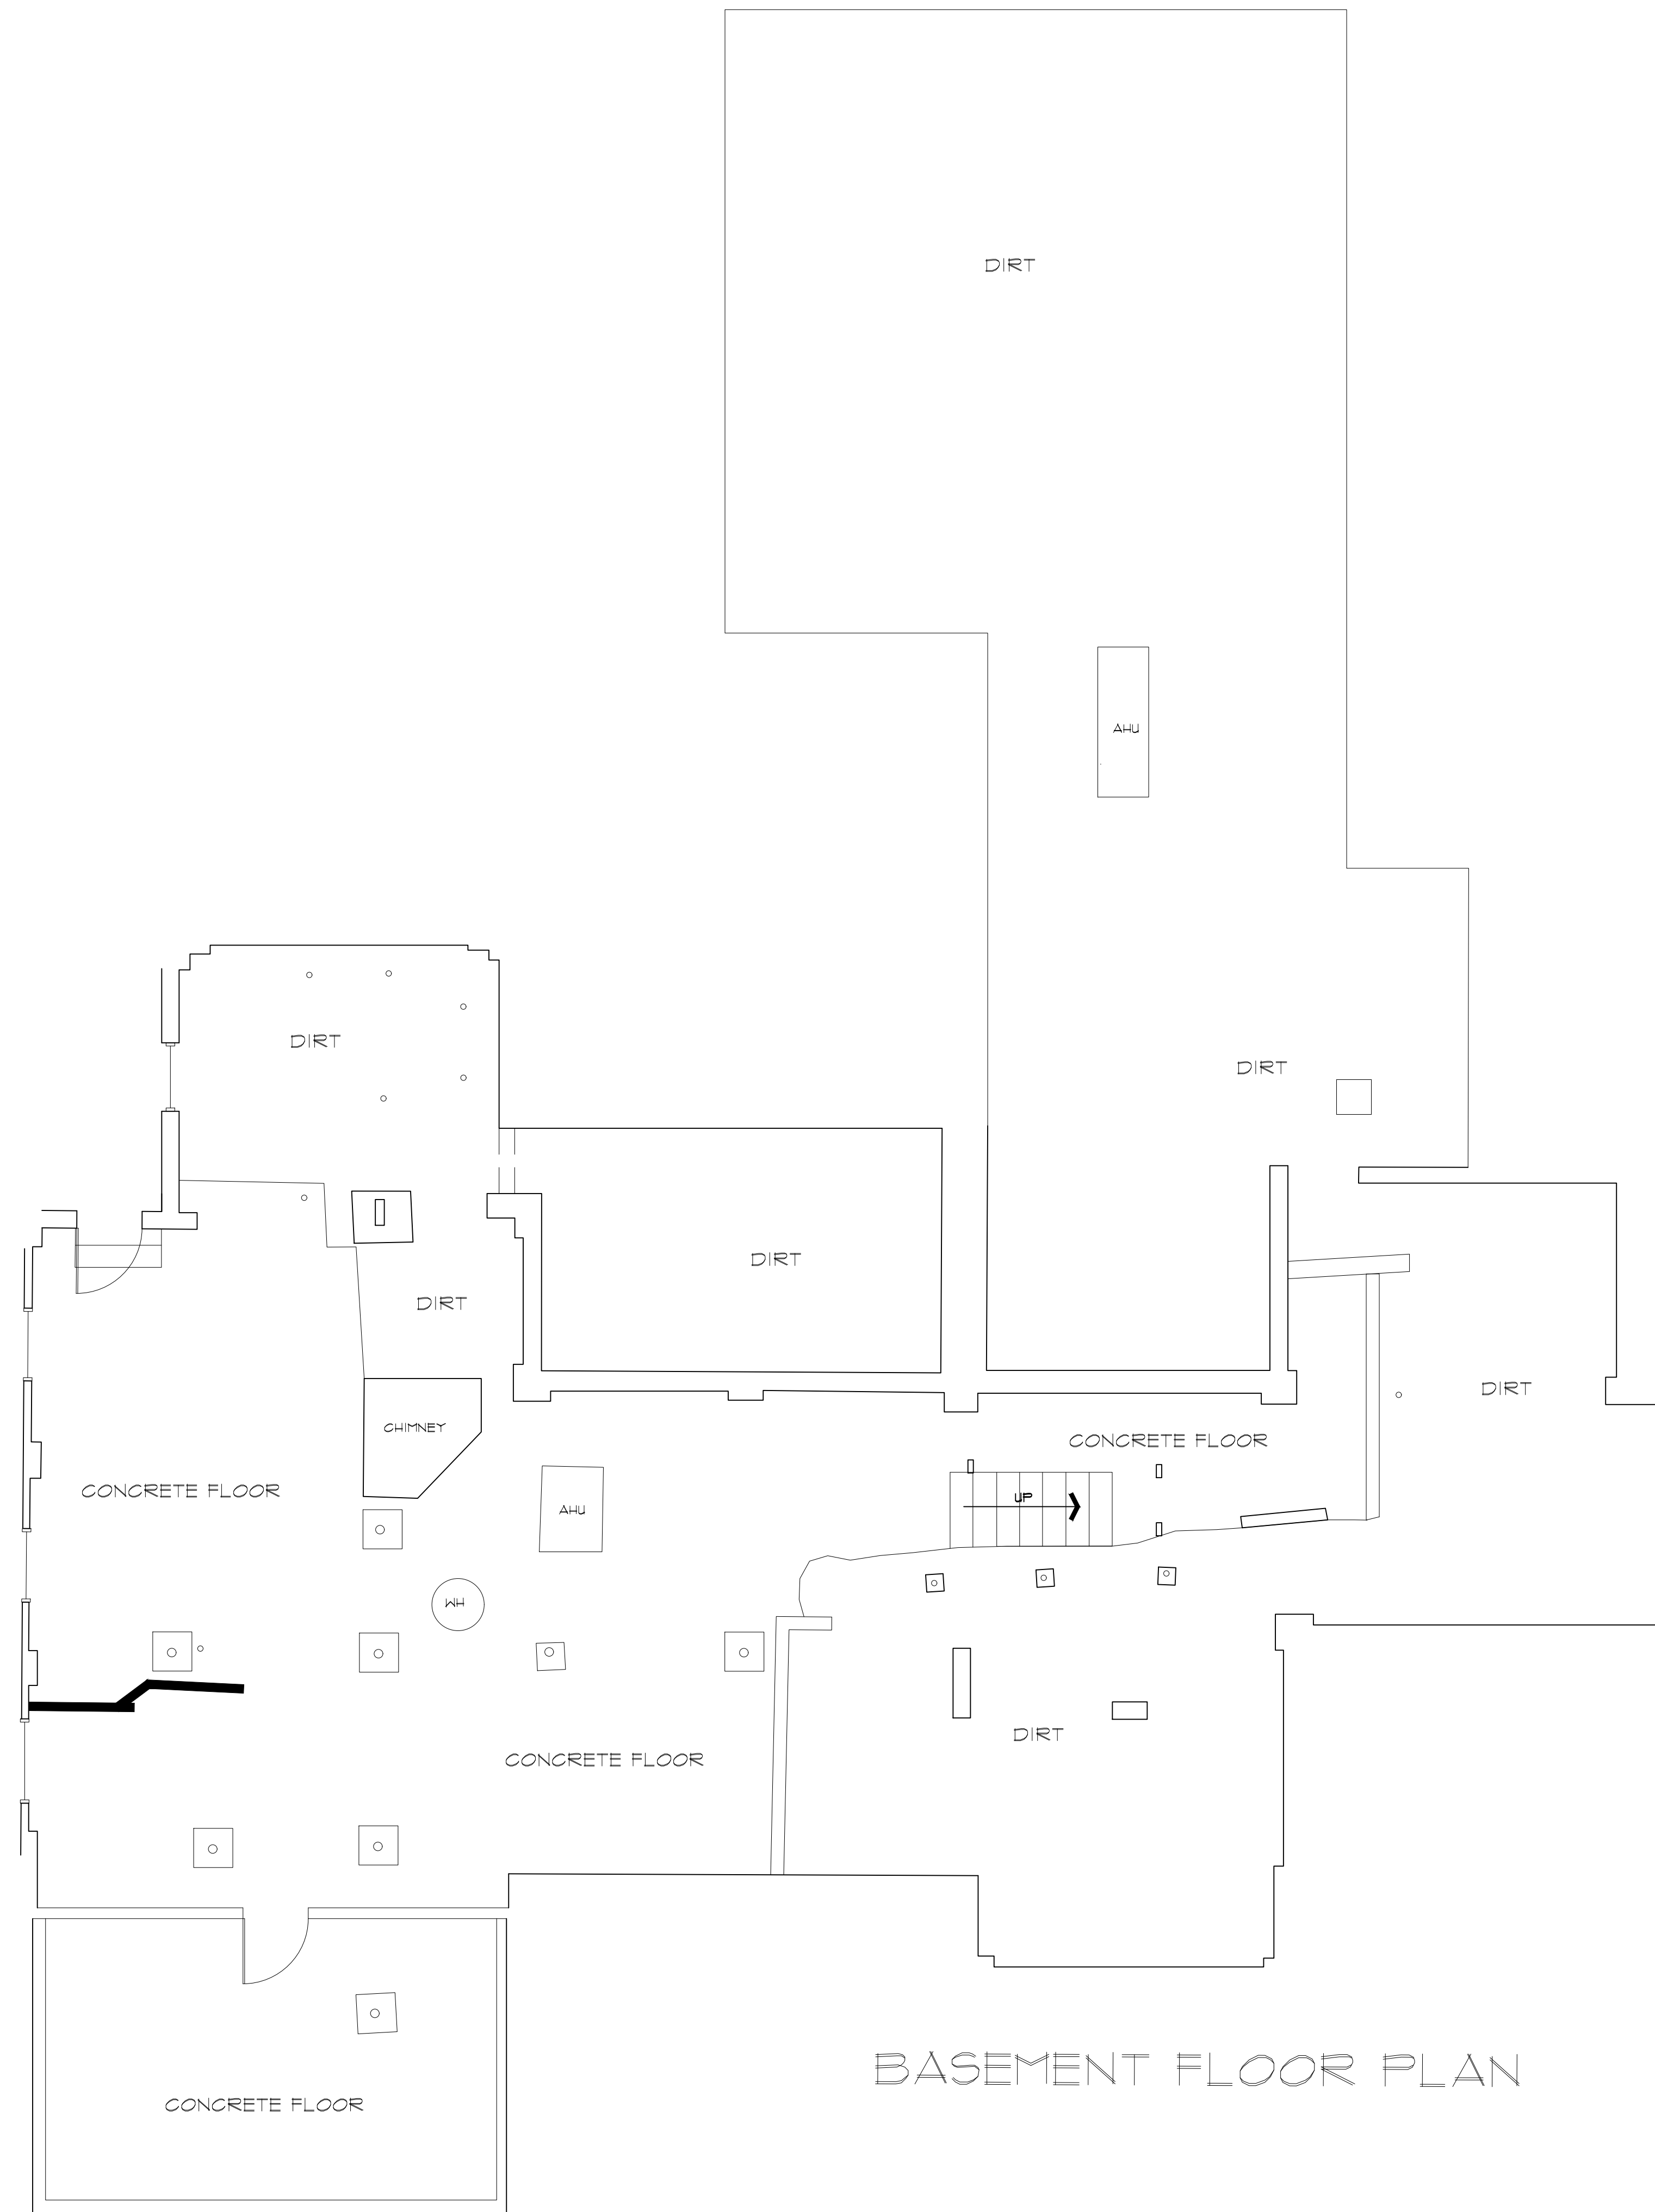


DETACHED GARAGE




ARCHITECTURAL AS BUILT

ATLANTA, GA 30305

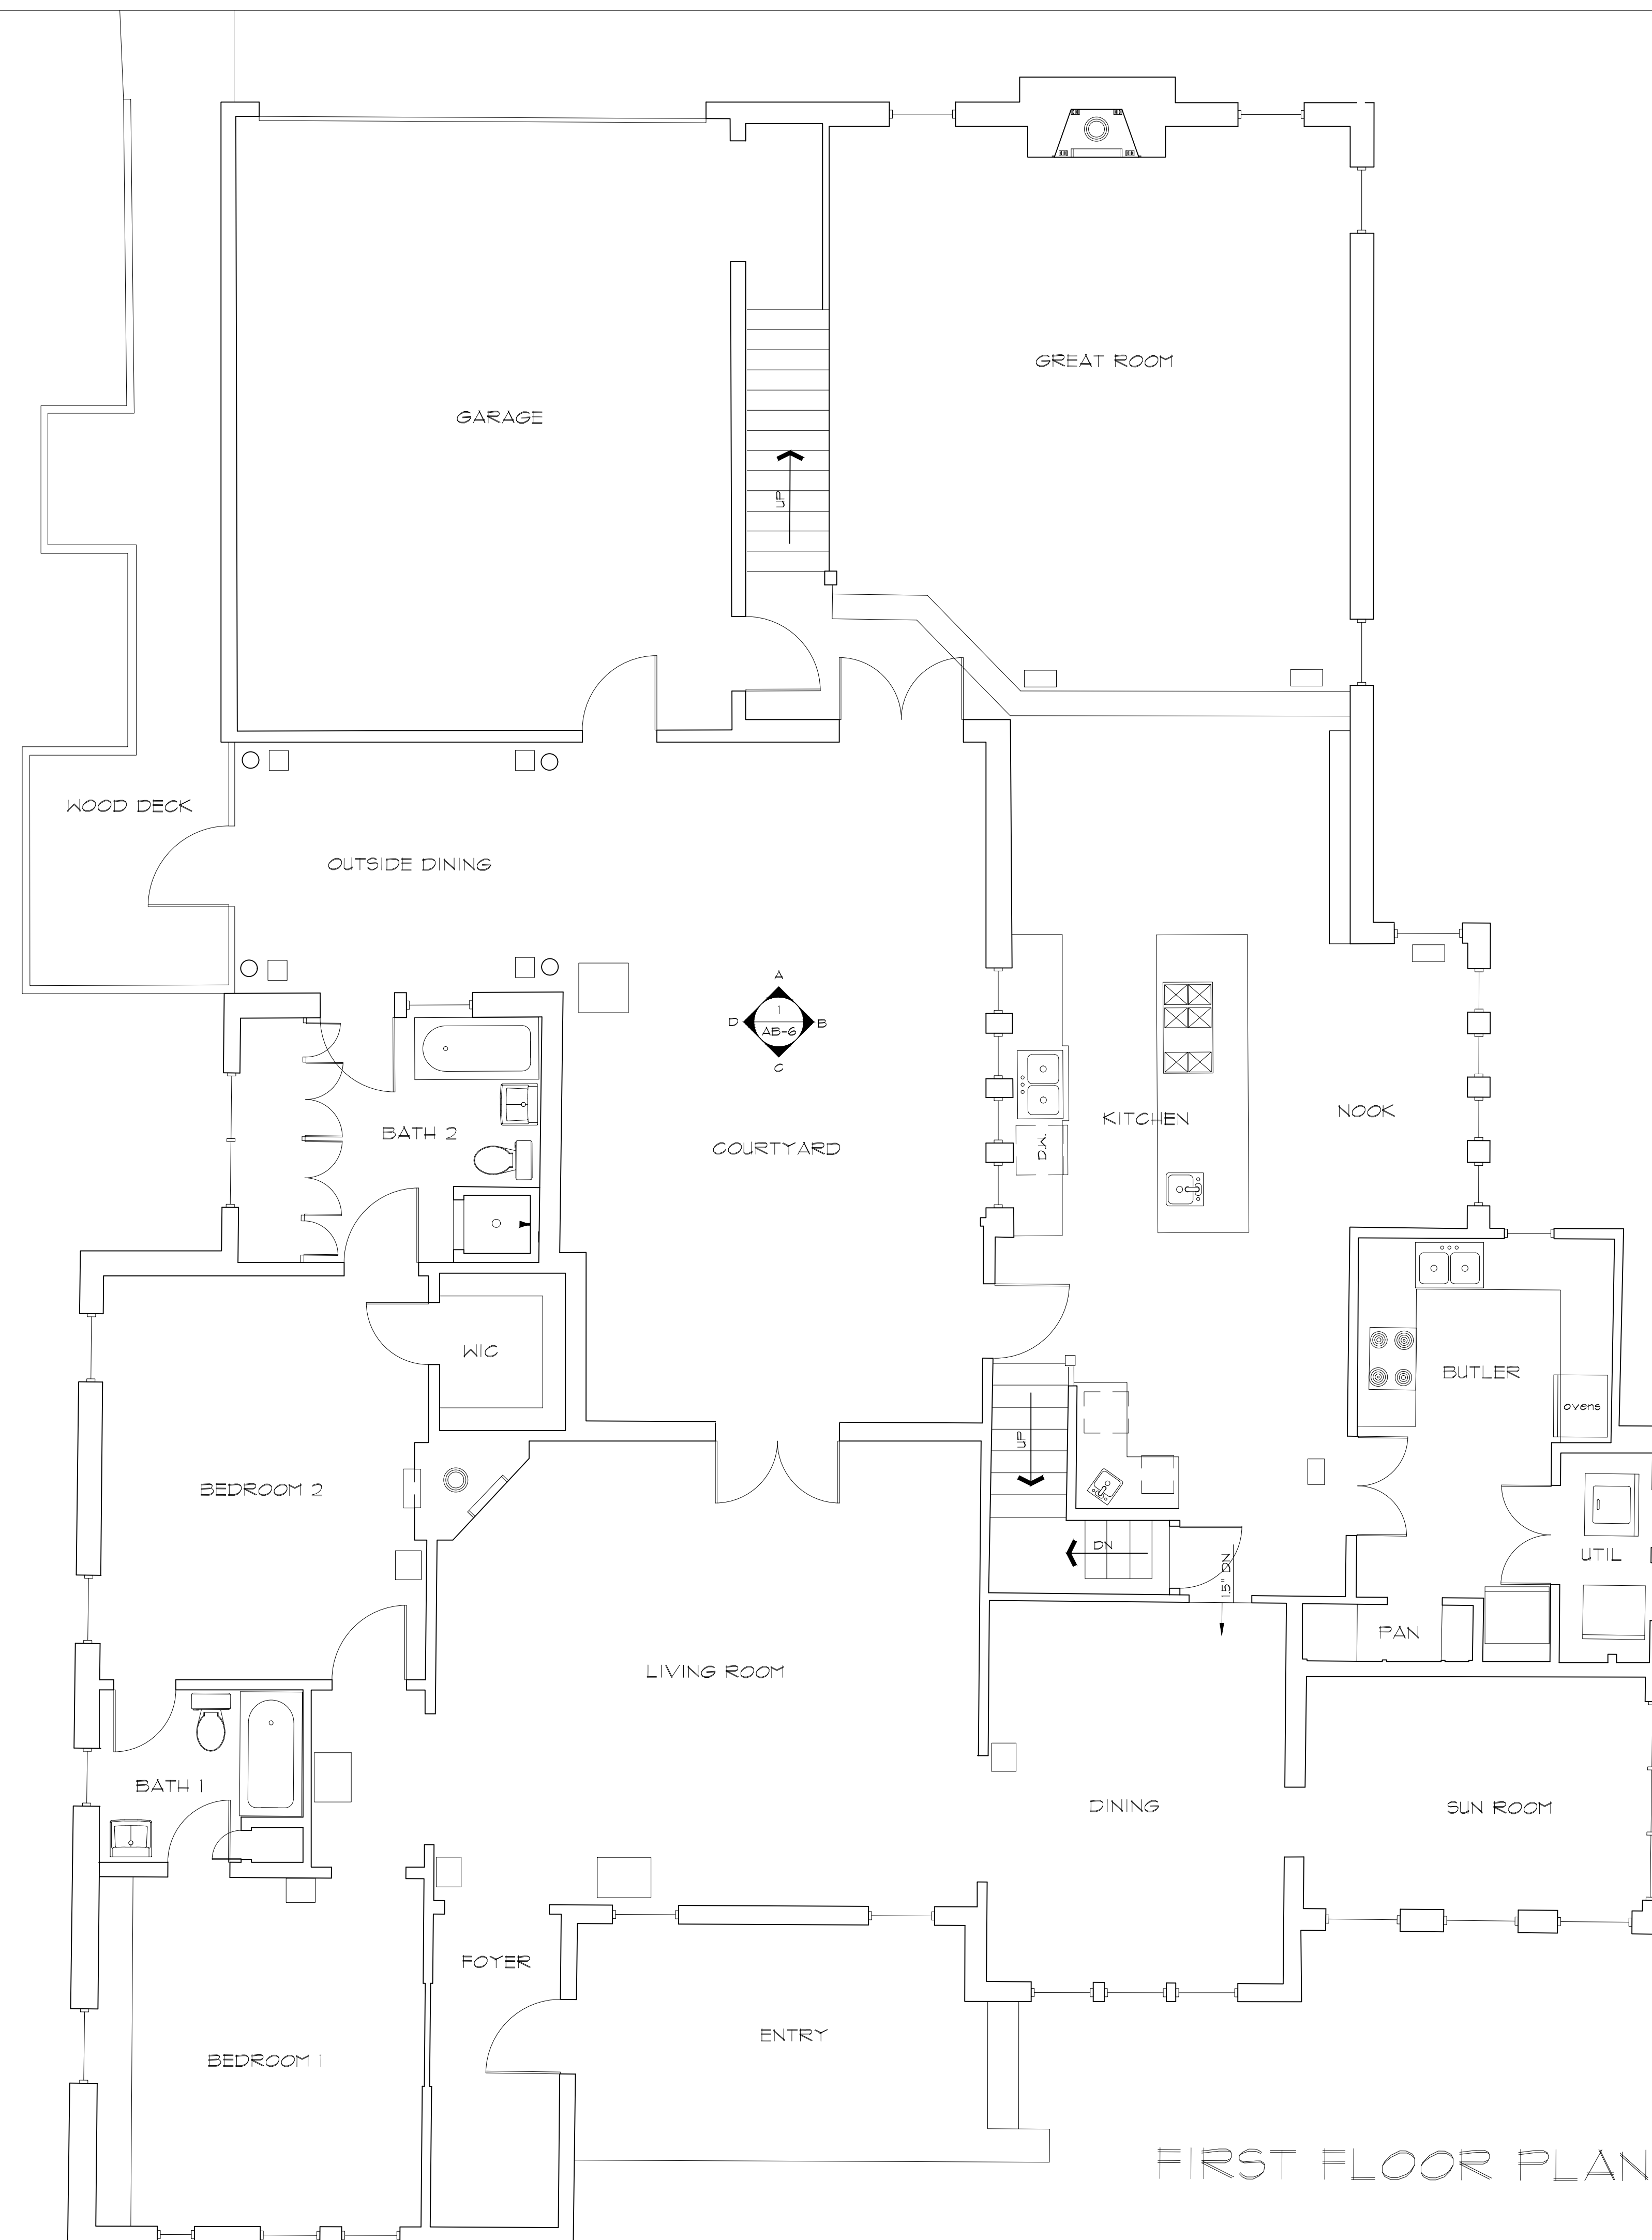

01	100% SUBMISSION	SEE COVER SHEET
NO.	ISSUES REVISIONS	DATE
		SHEET TITLE
HL	PROJECT MANAGER	
HL	PROJECT DIRECTOR	
012318-1	PROJECT NUMBER	
1/4"=1'-0"		SCALE
CL	DRAWN BY	
		SHEET NUMBER

AB-2

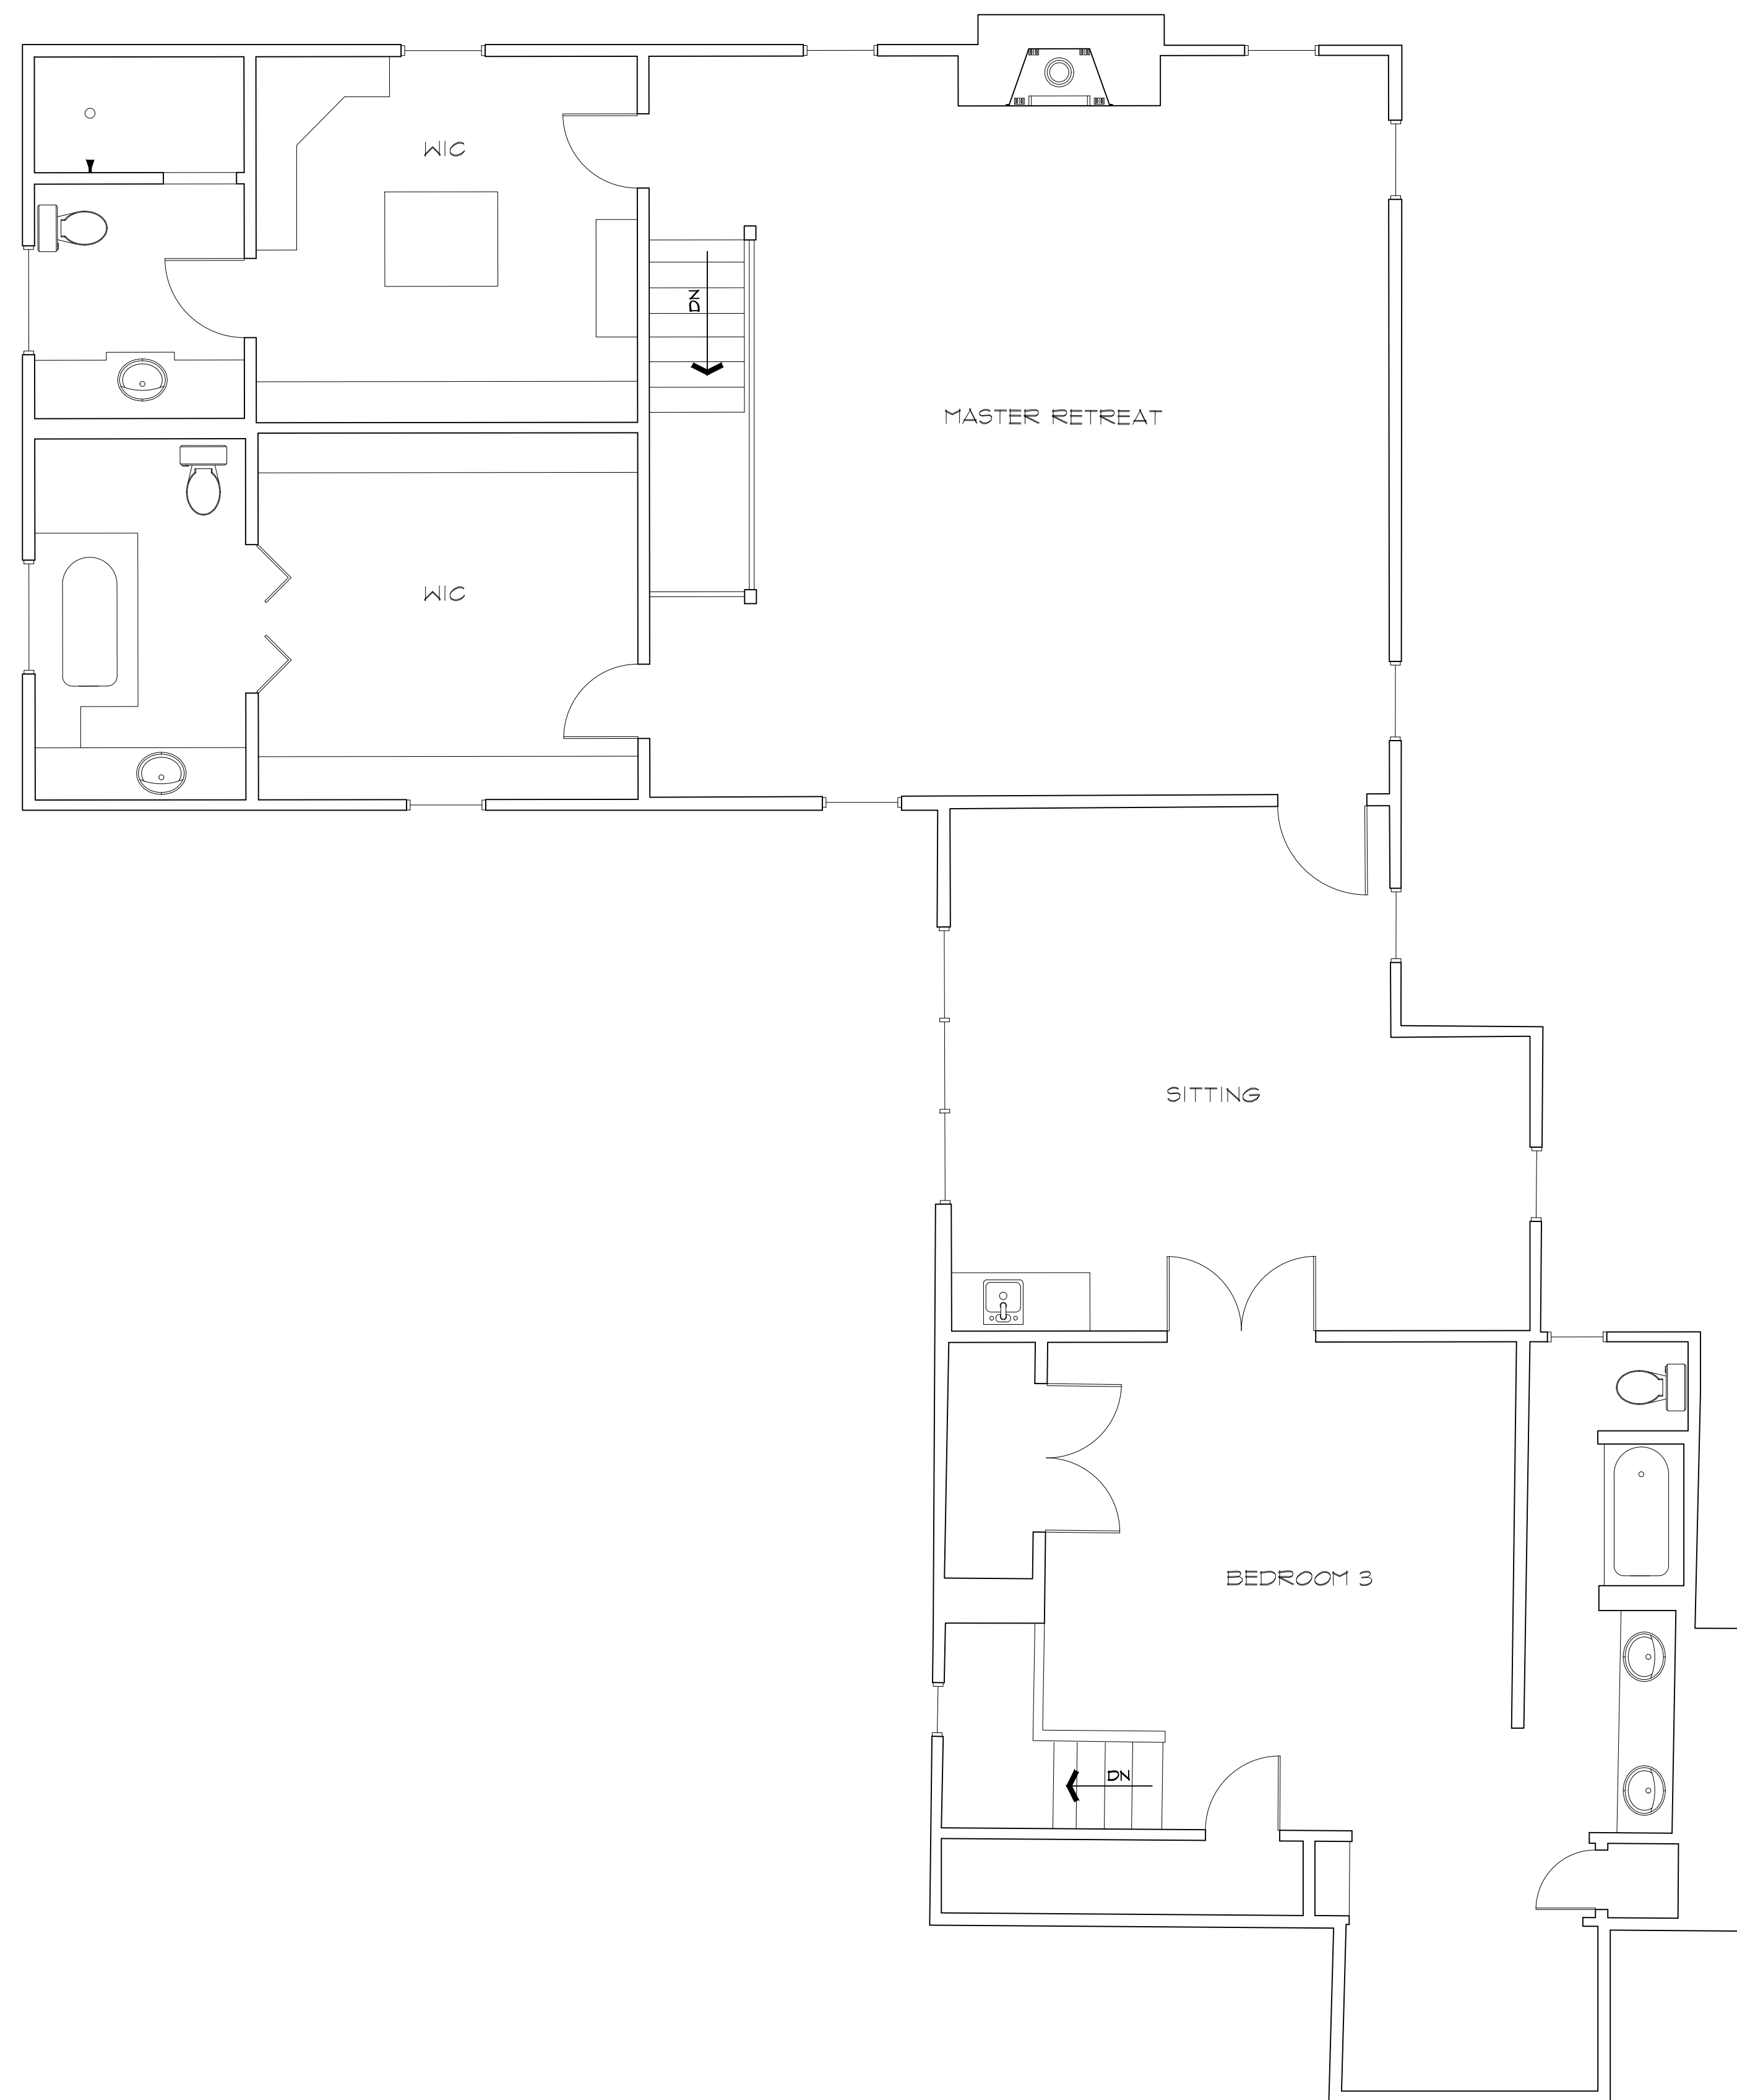

SECOND FLOOR PLAN

ARCHITECTURAL AS BUILT

ATLANTA, GA 30305

01	100% SUBMISSION	SEE COVER SHEET
NO.	ISSUES REVISIONS	DATE
		SHEET TITLE
H/L	PROJECT MANAGER	
H/L	PROJECT DIRECTOR	
012318-1	PROJECT NUMBER	
1/4"=1'-0"	SCALE	
CL	DRAWN BY	
		SHEET NUMBER
AB-3		



FRONT ELEVATION



REAR ELEVATION



ARCHITECTURAL AS BUILT

ATLANTA, GA 30305

01	100% SUBMISSION	SEE COVER SHEET
NO.	ISSUES REVISIONS	DATE
		SHEET TITLE
H/L		PROJECT MANAGER
H/L		PROJECT DIRECTOR
012318-1		PROJECT NUMBER
1/4"=1'-0"		SCALE
CL		DRAWN BY
		SHEET NUMBER
AB-4		



RIGHT SIDE ELEVATION



LEFT SIDE ELEVATION

ARCHITECTURAL AS BUILT

ATLANTA, GA 30305

[illegible]

AB-5

