

AS-BUILT DOCUMENTATION


Ridgewood, NJ 07450



100% SUBMITTAL

DRAWING INDEX

- C-1 COVER SHEET | DRAWING INDEX
- SL SYMBOLS LEGEND
- AB-1 BASEMENT AND ROOF PLAN
- AB-2 FIRST FLOOR PLAN
- AB-3 SECOND FLOOR PLAN
- AB-4 THIRD FLOOR PLAN
- AB-5 FRONT AND REAR ELEVATIONS
- AB-6 SIDE ELEVATIONS
- AB-7 BUILDING SECTION PER ARCHITECTS REQUEST

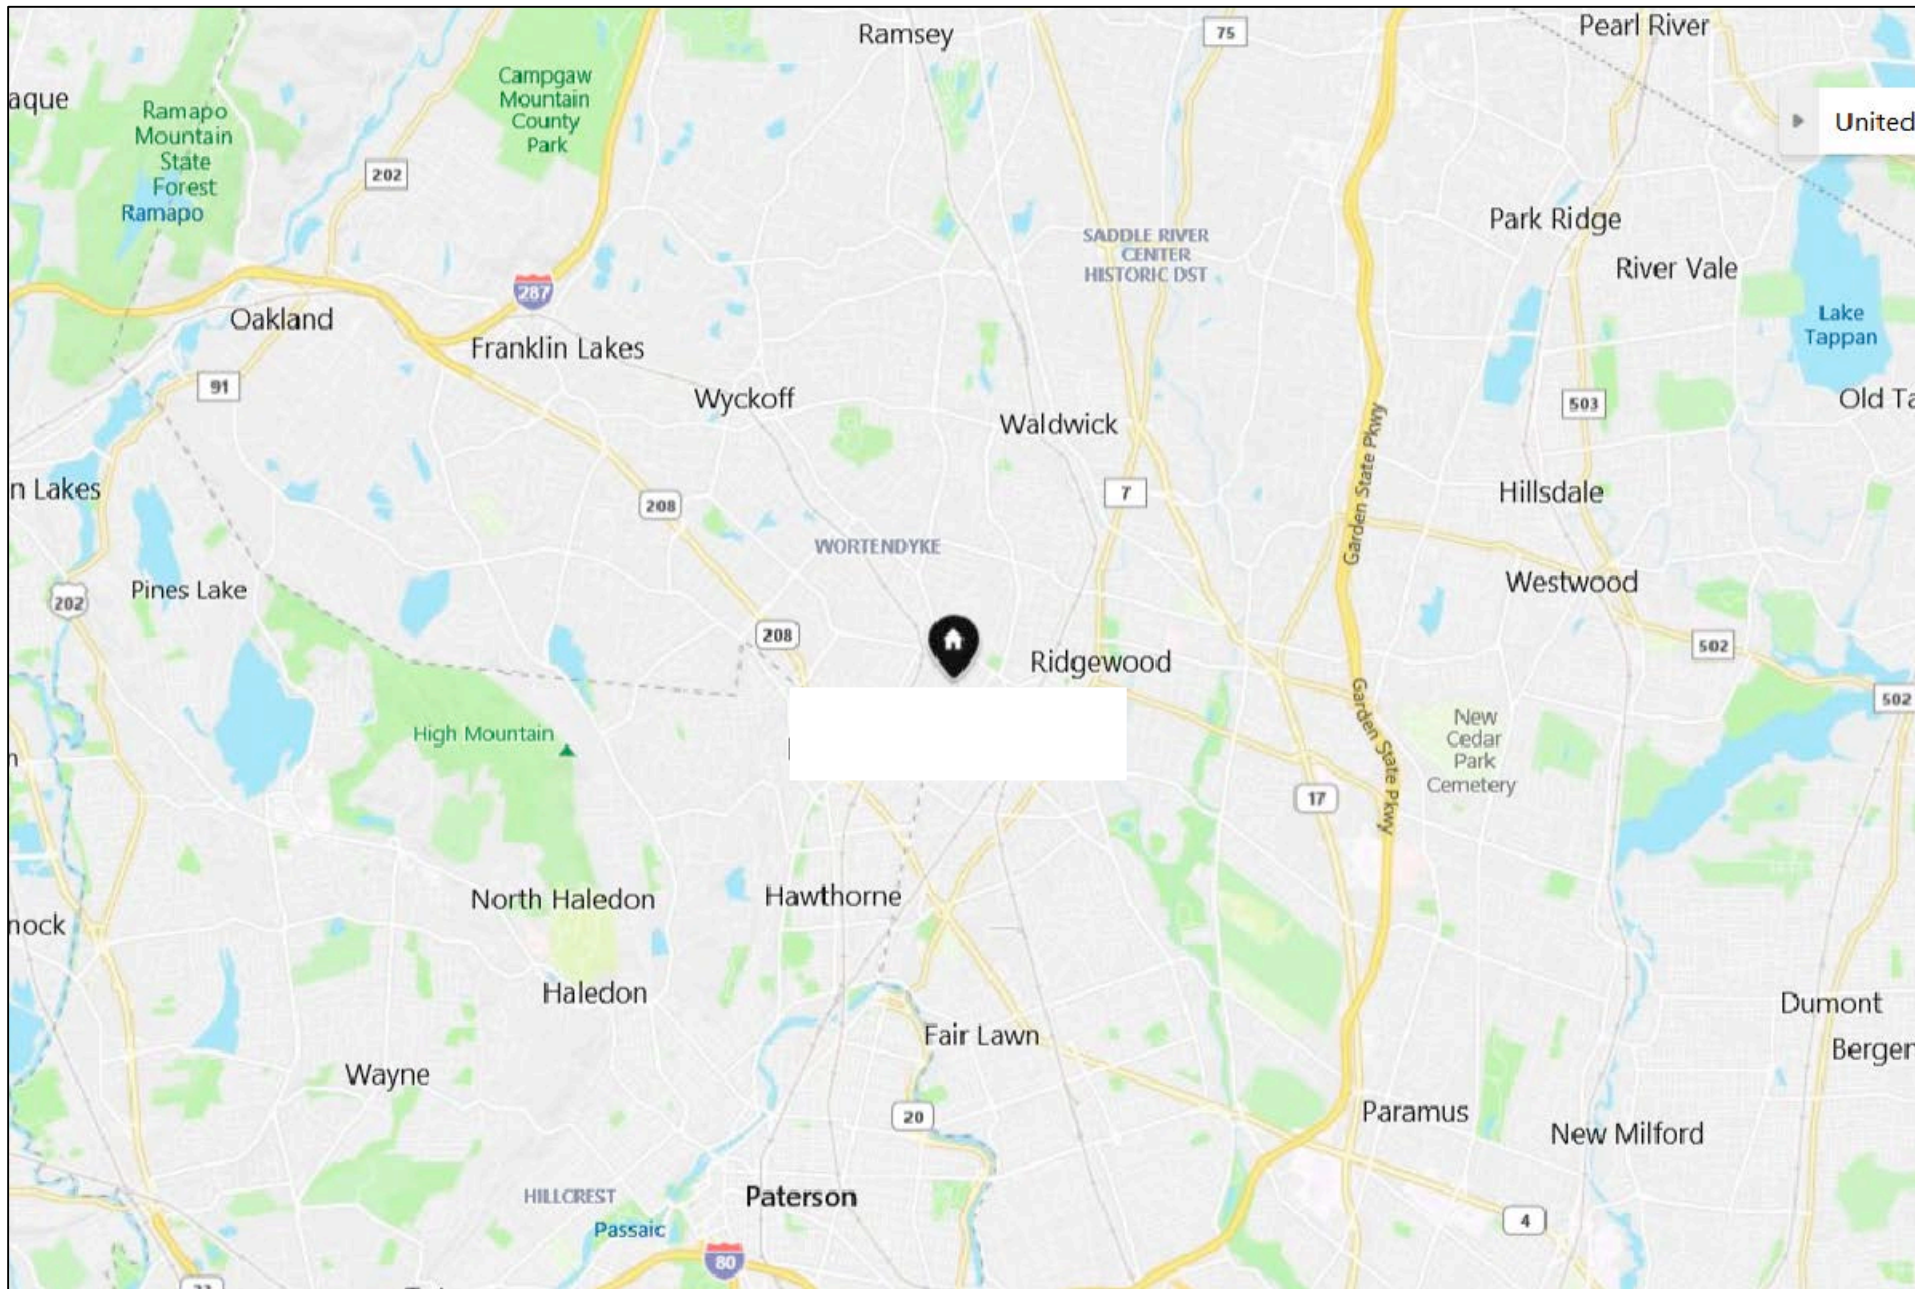

VICINITY MAP NTS

AREA DATA	
LIVING BASEMENT	1,459 S.F. ±
LIVING FIRST FLOOR	1,571 S.F. ±
LIVING SECOND FLOOR	1,427 S.F. ±
LIVING THIRD FLOOR	1,023 S.F. ±
TERRACE	417 S.F. ±
GARAGE	465 S.F. ±
ENTRY	48 S.F. ±
TOTAL LIVING	5,480 S.F. ±
GRAND TOTAL	6,410 S.F. ±

AS BUILT

PROFESSIONALS

www.asbuiltprofessionals.com

A DIVISION OF:

AEC

CONSULTANTS INC

844.272.8458

844 AS BUILT

© 2019 AEC CONSULTANTS INC

ARCHITECTURAL AS BUILT
Ridgewood, NJ 07450

01100% SUBMISSION

NO. ISSUES | REVISIONS

DATE

SHEET TITLE

COVER SHEET

HLPROJECT MANAGER

HLPROJECT DIRECTOR

012317-1PROJECT NUMBER

SCALE

CLDRAWN BY

SHEET NUMBER







 
 
 
 


 

C-1

SYMBOLS LEGEND








RCP

	EXHAUST VENT		TRACK LIGHT OR VANITY LIGHT
	CEILING MOUNTED LIGHT FIXTURE		WALL-MOUNTED LIGHT FIXTURE
	CEILING MOUNTED DIRECTIONAL LIGHT		EMERGENCY EXIT SIGN
	RECESSED CAN LIGHT		EMERGENCY EXIT LIGHT
	EYEBALL OR SMALL CAN LIGHT		EMERGENCY EXIT LIGHT W/ SIGN
	PENDANT LIGHT		LIGHTED STAIR SIGN
	INDIVIDUAL FLUOR. LAY-IN FIXTURE 4 BULB		FLOOD LIGHT
	INDIVIDUAL FLUOR. HANGING FIXTURE 2 BULB		PHOTO CELL
	INDIVIDUAL FLUOR. FLUSH MOUNT FIXTURE 4 BULB		CEILING FAN
	CAMERA		CEILING FAN W/ LIGHT KIT
	MOTION DET.	<div>7-2-6</div>	CEILING HEIGHT AND TRIM 7'-2" ABOVE FLOOR BELOW WITH 6" CROWN MOULDING. NOTE: ALL CEILINGS NOT LABELED ARE PLASTER. CEILINGS SHOWN WITH A GRID ARE LAY IN ACOUSTICAL TILE..
	SUPPLY VENT		
	SUPPLY VENT		
	RETURN VENT		
	RETURN VENT		JUNCTION BOX
	SPEAKER		





 

ELECTRIC

	DATA OUTLET
	TELEPHONE JACK
	ELECTRIC SWITCH
	CABLE TELEVISION OUTLET
	DUPLEX RECEPTACLE OUTLET
	SPECIAL PURPOSE CONNECTION OR OUTLET
	QUADRUPLUX RECEPTACLE OUTLET
	FLOOR DUPLEX RECEPTACLE OUTLET
	ELECTRIC PANEL
	ELECTRIC METER
	BUTTON SWITCH
	DISCONNECT SWITCH
	GROUND/FLOOR LIGHT
	KEY PAD

FIRE PROTECTION

	FIRE EXTINGUISHER
	FIRE PULL
	FIRE ALARM (HORN/SRTOBE)
	SMOKE DETECTOR
	SMOKE ALARM SPEAKER
	SPRINKLER HEAD CEILING MOUNT
	SPRINKLER HEAD WALL MOUNT

MEP

	THERMOSTAT
	FLOOR DRAIN
	VALVE
	HOSE BIB
	WATER SUPPLY
	SUSPENDED GAS HEATER

MISC

	BOLLARD
	SPOT ELEVATION

7-2-6

CEILING HEIGHT AND TRIM 7'-2" ABOVE FLOOR BELOW WITH 6" CROWN MOULDING. NOTE: ALL CEILINGS NOT LABELED ARE PLASTER. CEILINGS SHOWN WITH A GRID ARE LAY IN ACOUSTICAL TILE..

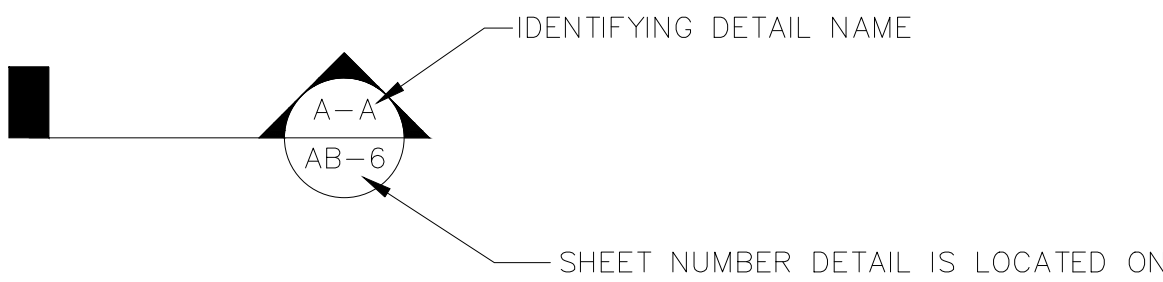
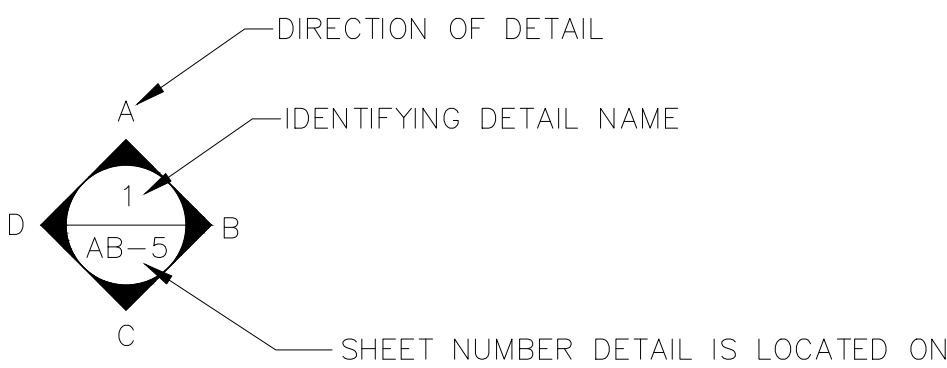


PHOTO DOCUMENTATION LEGEND

- INDICATES LOCATION OF CAMERA
- INDICATES DIRECTION OF CAMERA LENS AND CORRESPONDING PHOTO / VIDEO NUMBER

TYPES OF DOCUMENTATION

	001		V-001			
GROUND BASED PHOTO		GROUND BASED VIDEO		360° SPHERICAL PHOTO	AERIAL BASED PHOTO	AERIAL BASED VIDEO

As BUILT

PROFESSIONALS

www.asbuiltprofessionals.com

A DIVISION OF:

AEC

CONSULTANTS INC

844.272.8458


844 AS BUILT

© 2019 AEC CONSULTANTS INC

ARCHITECTURAL AS BUILT
Ridgewood, NJ 07450

01	100% SUBMISSION	
NO.	ISSUES REVISIONS	DATE
		SHEET TITLE
HL	PROJECT MANAGER	
HL	PROJECT DIRECTOR	
012317-1	PROJECT NUMBER	
NOT TO SCALE		SCALE
CL	DRAWN BY	
		SHEET NUMBER

SL

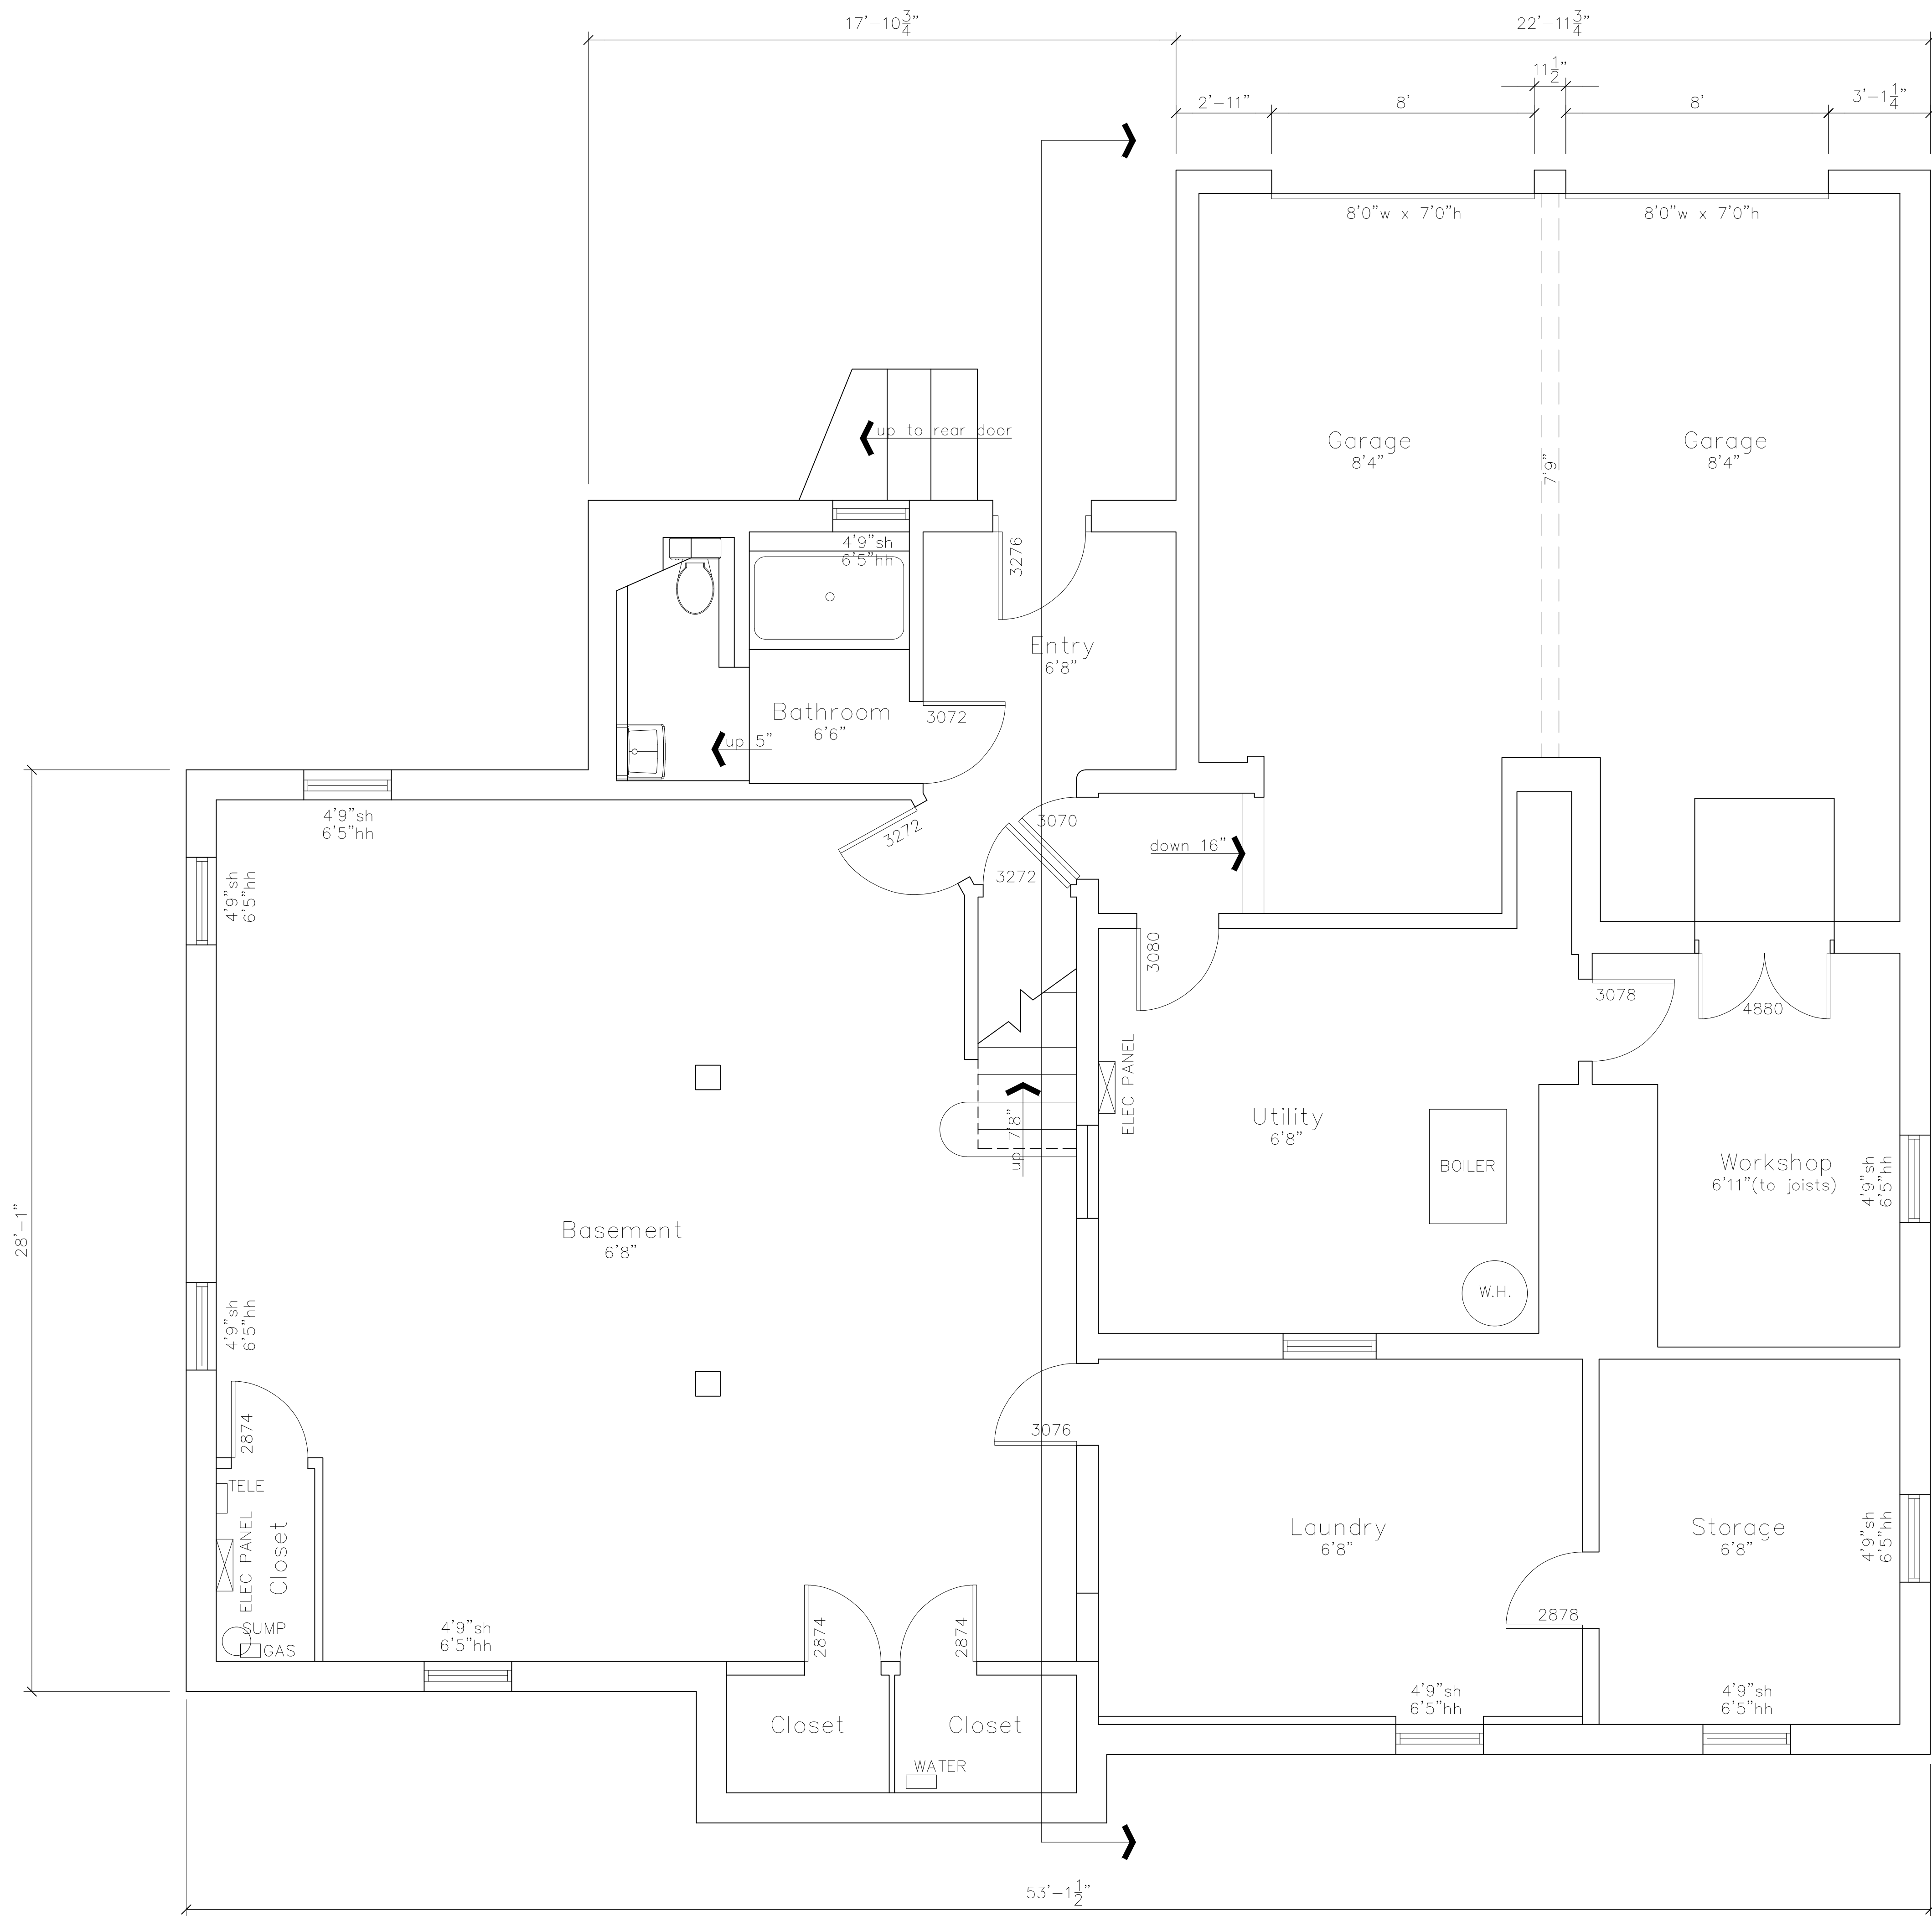

BASEMENT FLOOR PLAN

AS BUILT

PROFESSIONALS

www.asbuiltprofessionals.com

A DIVISION OF:

AEC

CONSULTANTS INC

844.272.8458

844 AS BUILT


© 2019 AEC CONSULTANTS INC

ARCHITECTURAL AS BUILT

Ridgewood, NJ 07450

01	100% SUBMISSION	
NO.	ISSUES REVISIONS	DATE
SHEET TITLE		
HL PROJECT MANAGER		
HL PROJECT DIRECTOR		
012317-1 PROJECT NUMBER		
3/8"=1'-0" SCALE		
CL DRAWN BY		
SHEET NUMBER		

AB-1

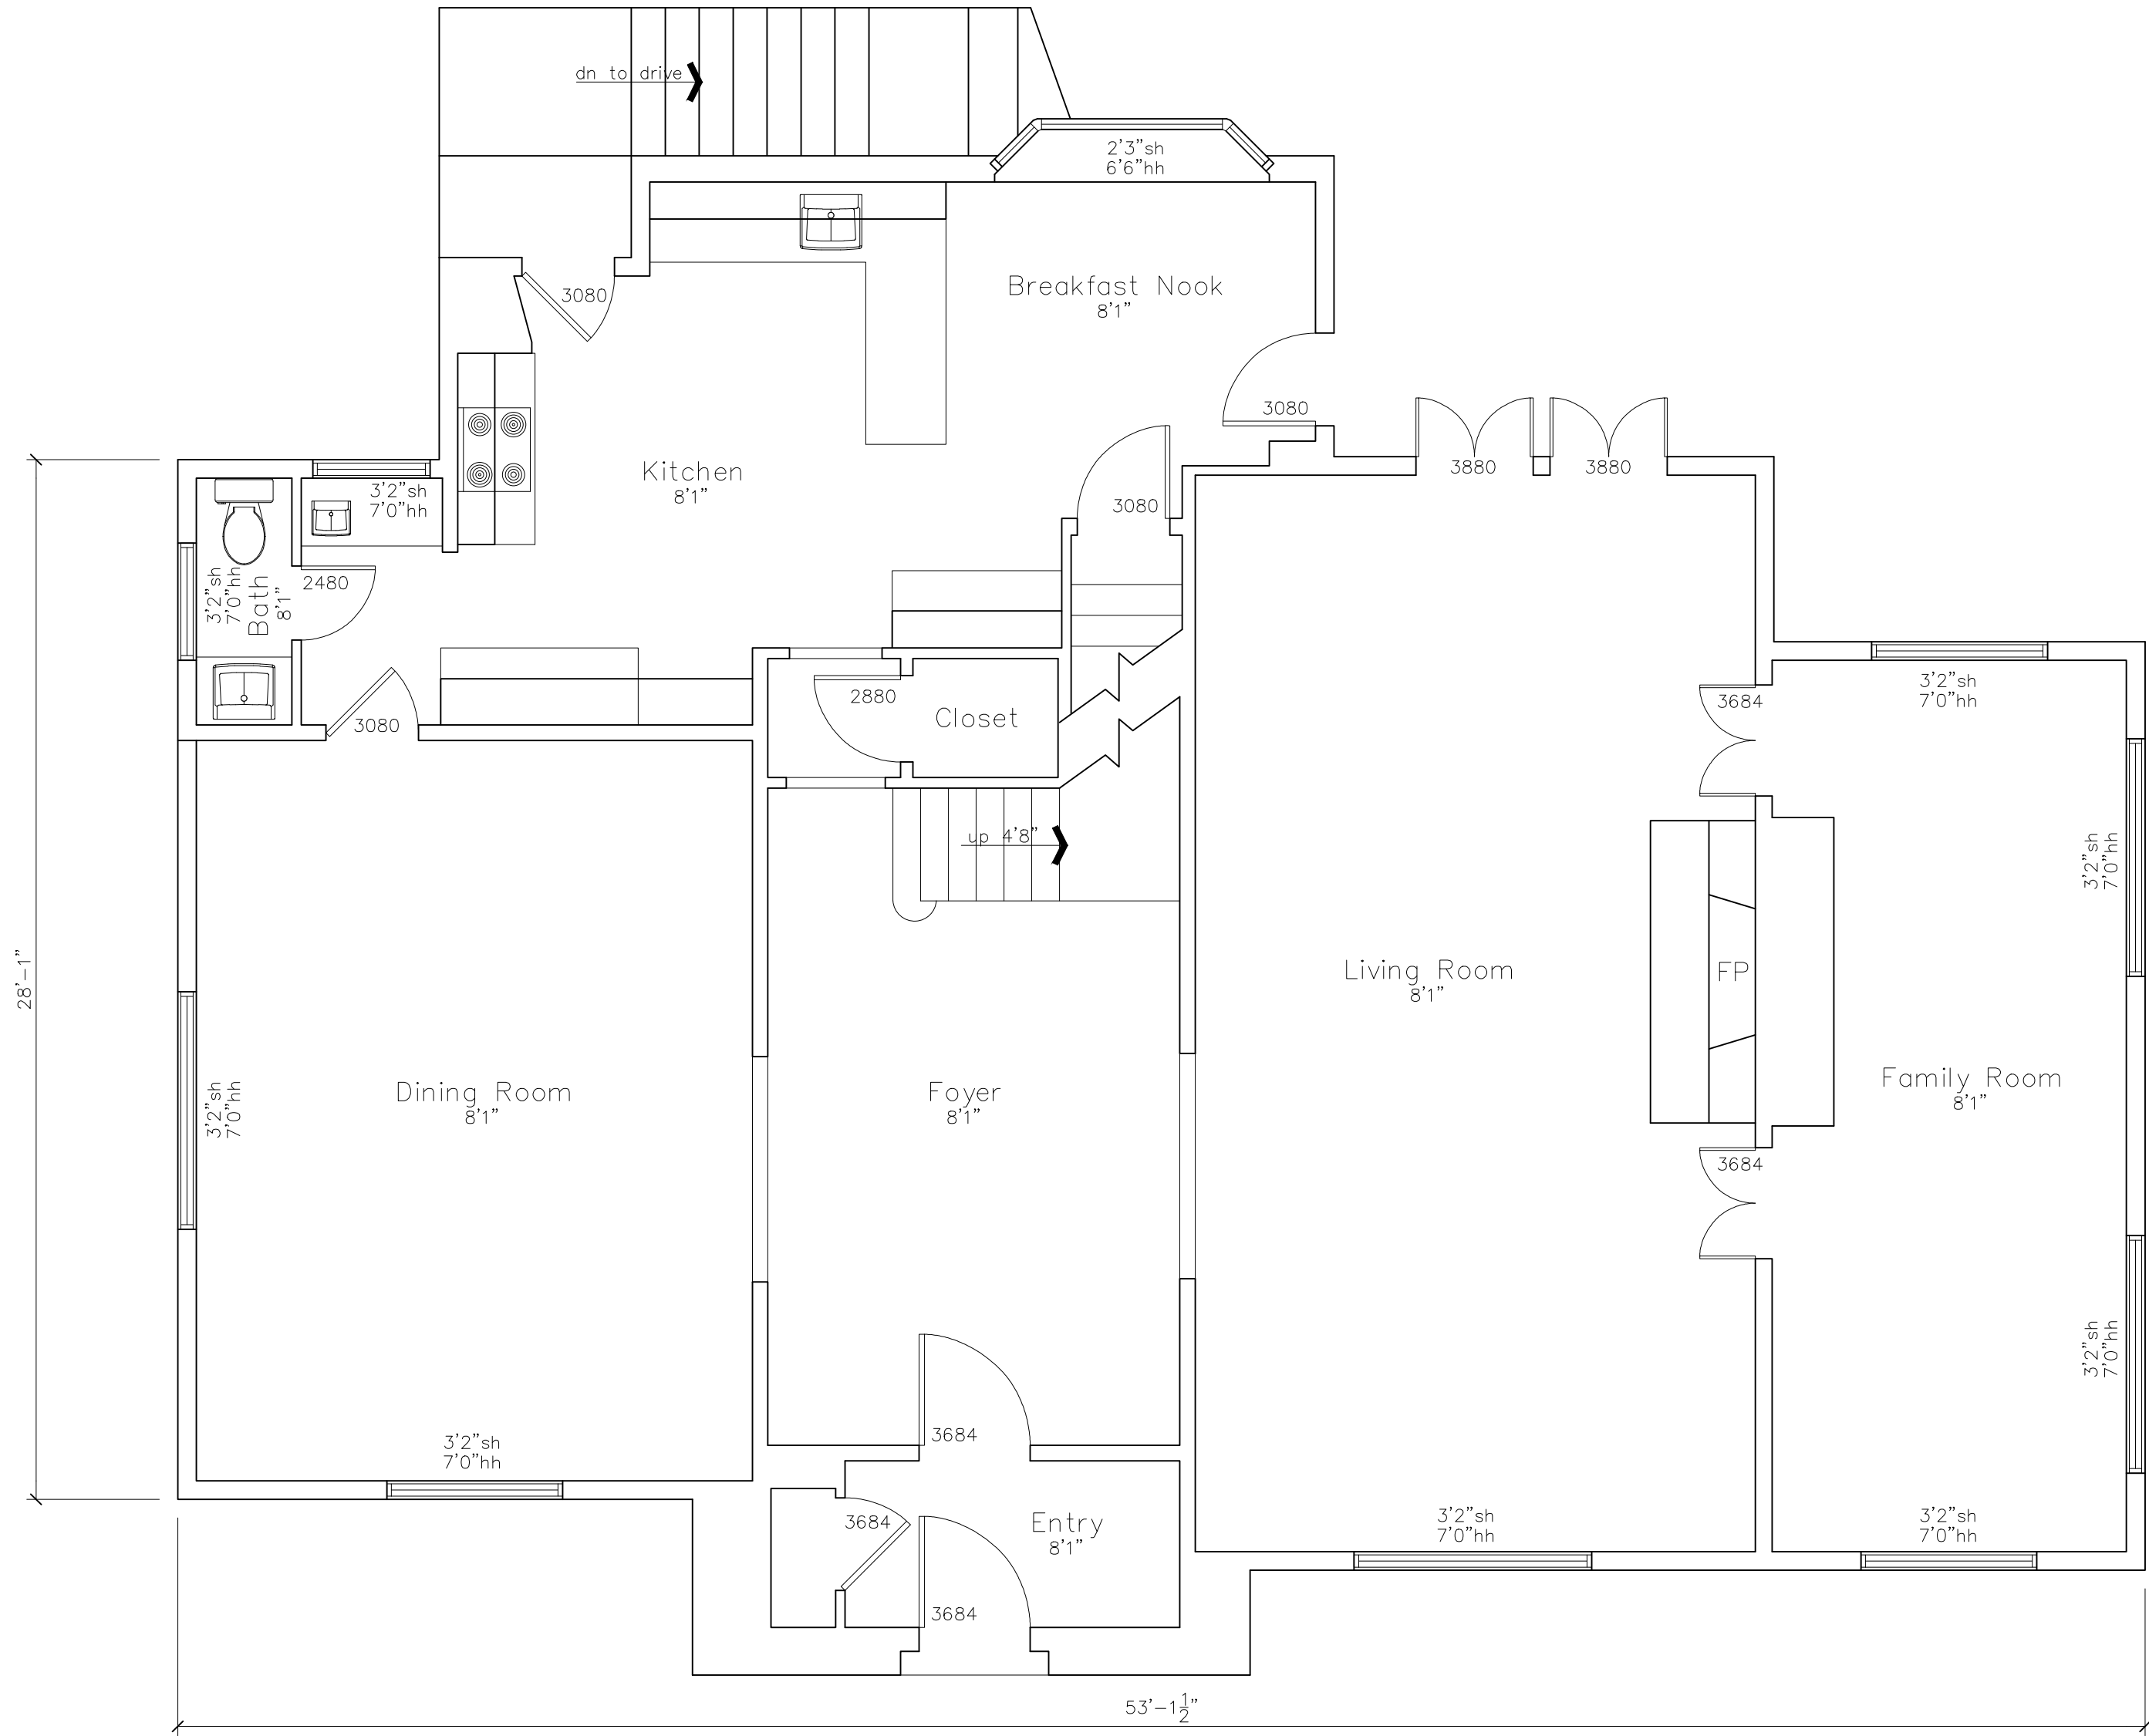

FIRST FLOOR PLAN

As BUILT

PROFESSIONALS

www.asbuiltprofessionals.com

A DIVISION OF:

AEC

CONSULTANTS INC

844.272.8458

844 AS BUILT

© 2019 AEC CONSULTANTS INC

ARCHITECTURAL AS BUILT

Ridgewood, NJ 07450

01	100% SUBMISSION	
NO.	ISSUES REVISIONS	DATE
SHEET TITLE		
HL	PROJECT MANAGER	
HL	PROJECT DIRECTOR	
012317-1	PROJECT NUMBER	
1/4"=1'-0"	SCALE	
CL	DRAWN BY	
SHEET NUMBER		
AB-2		





ARCHITECTURAL AS BUILT

Ridgewood, NJ 07450



AB-3

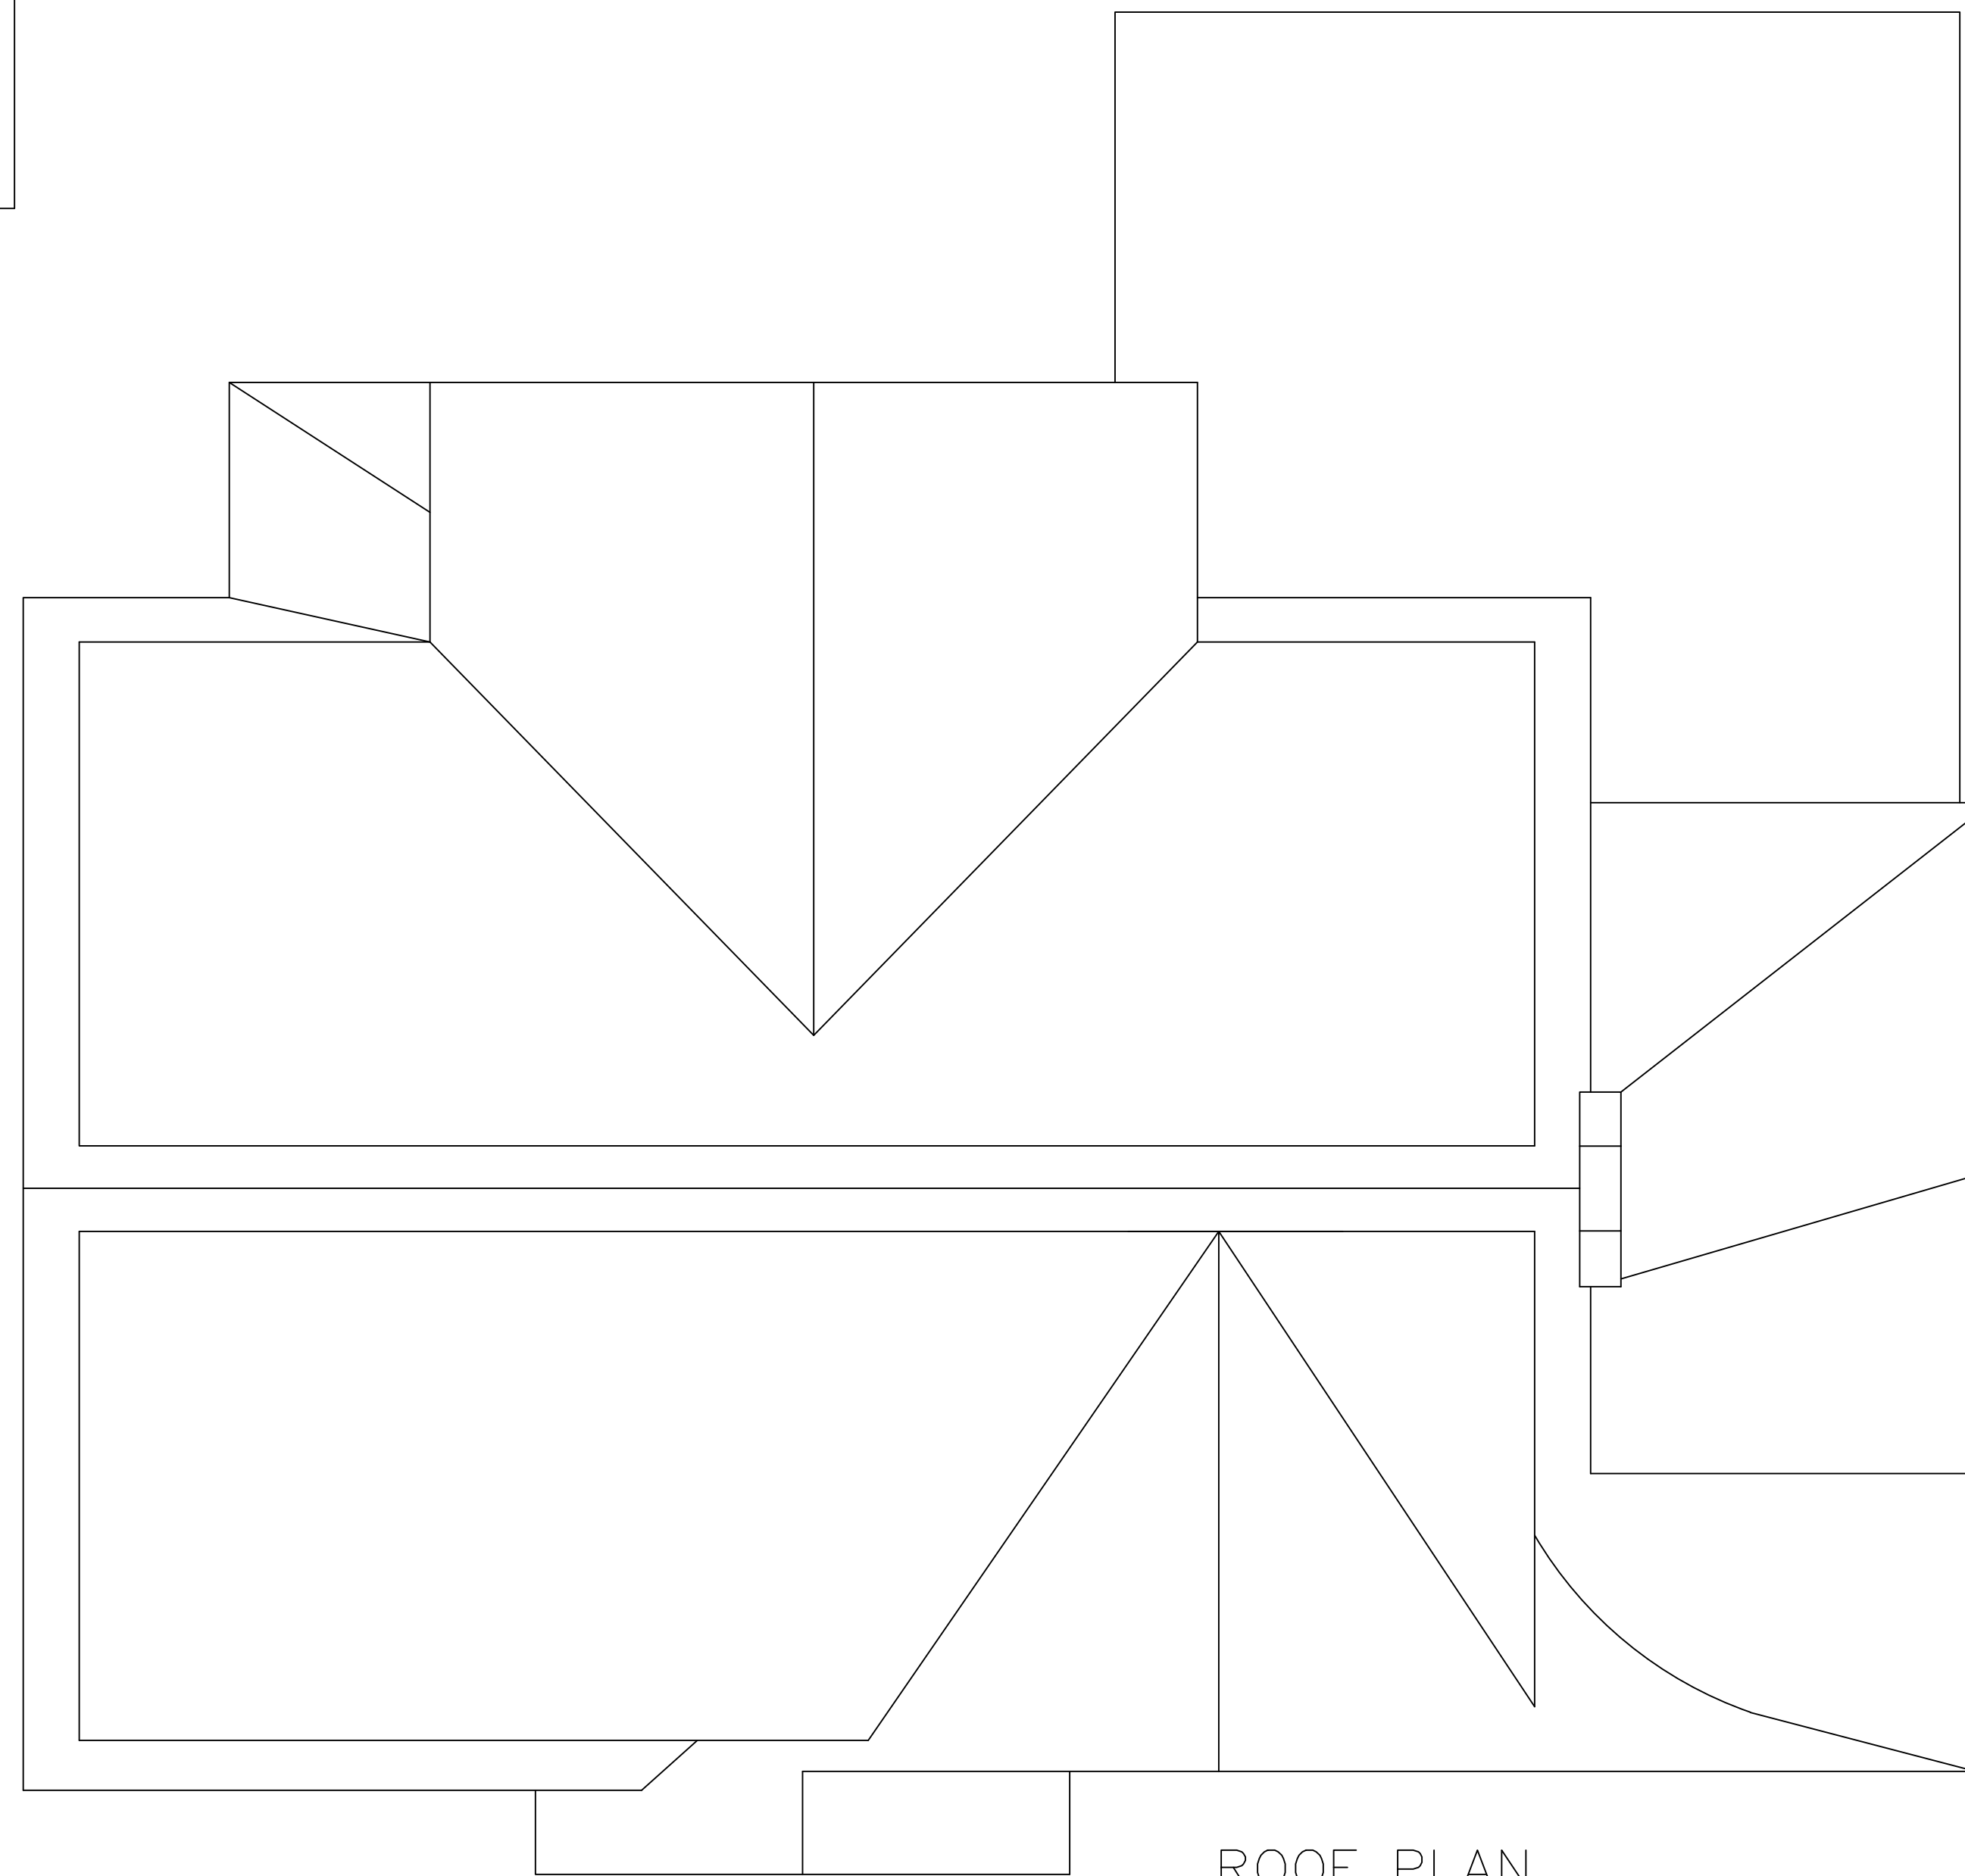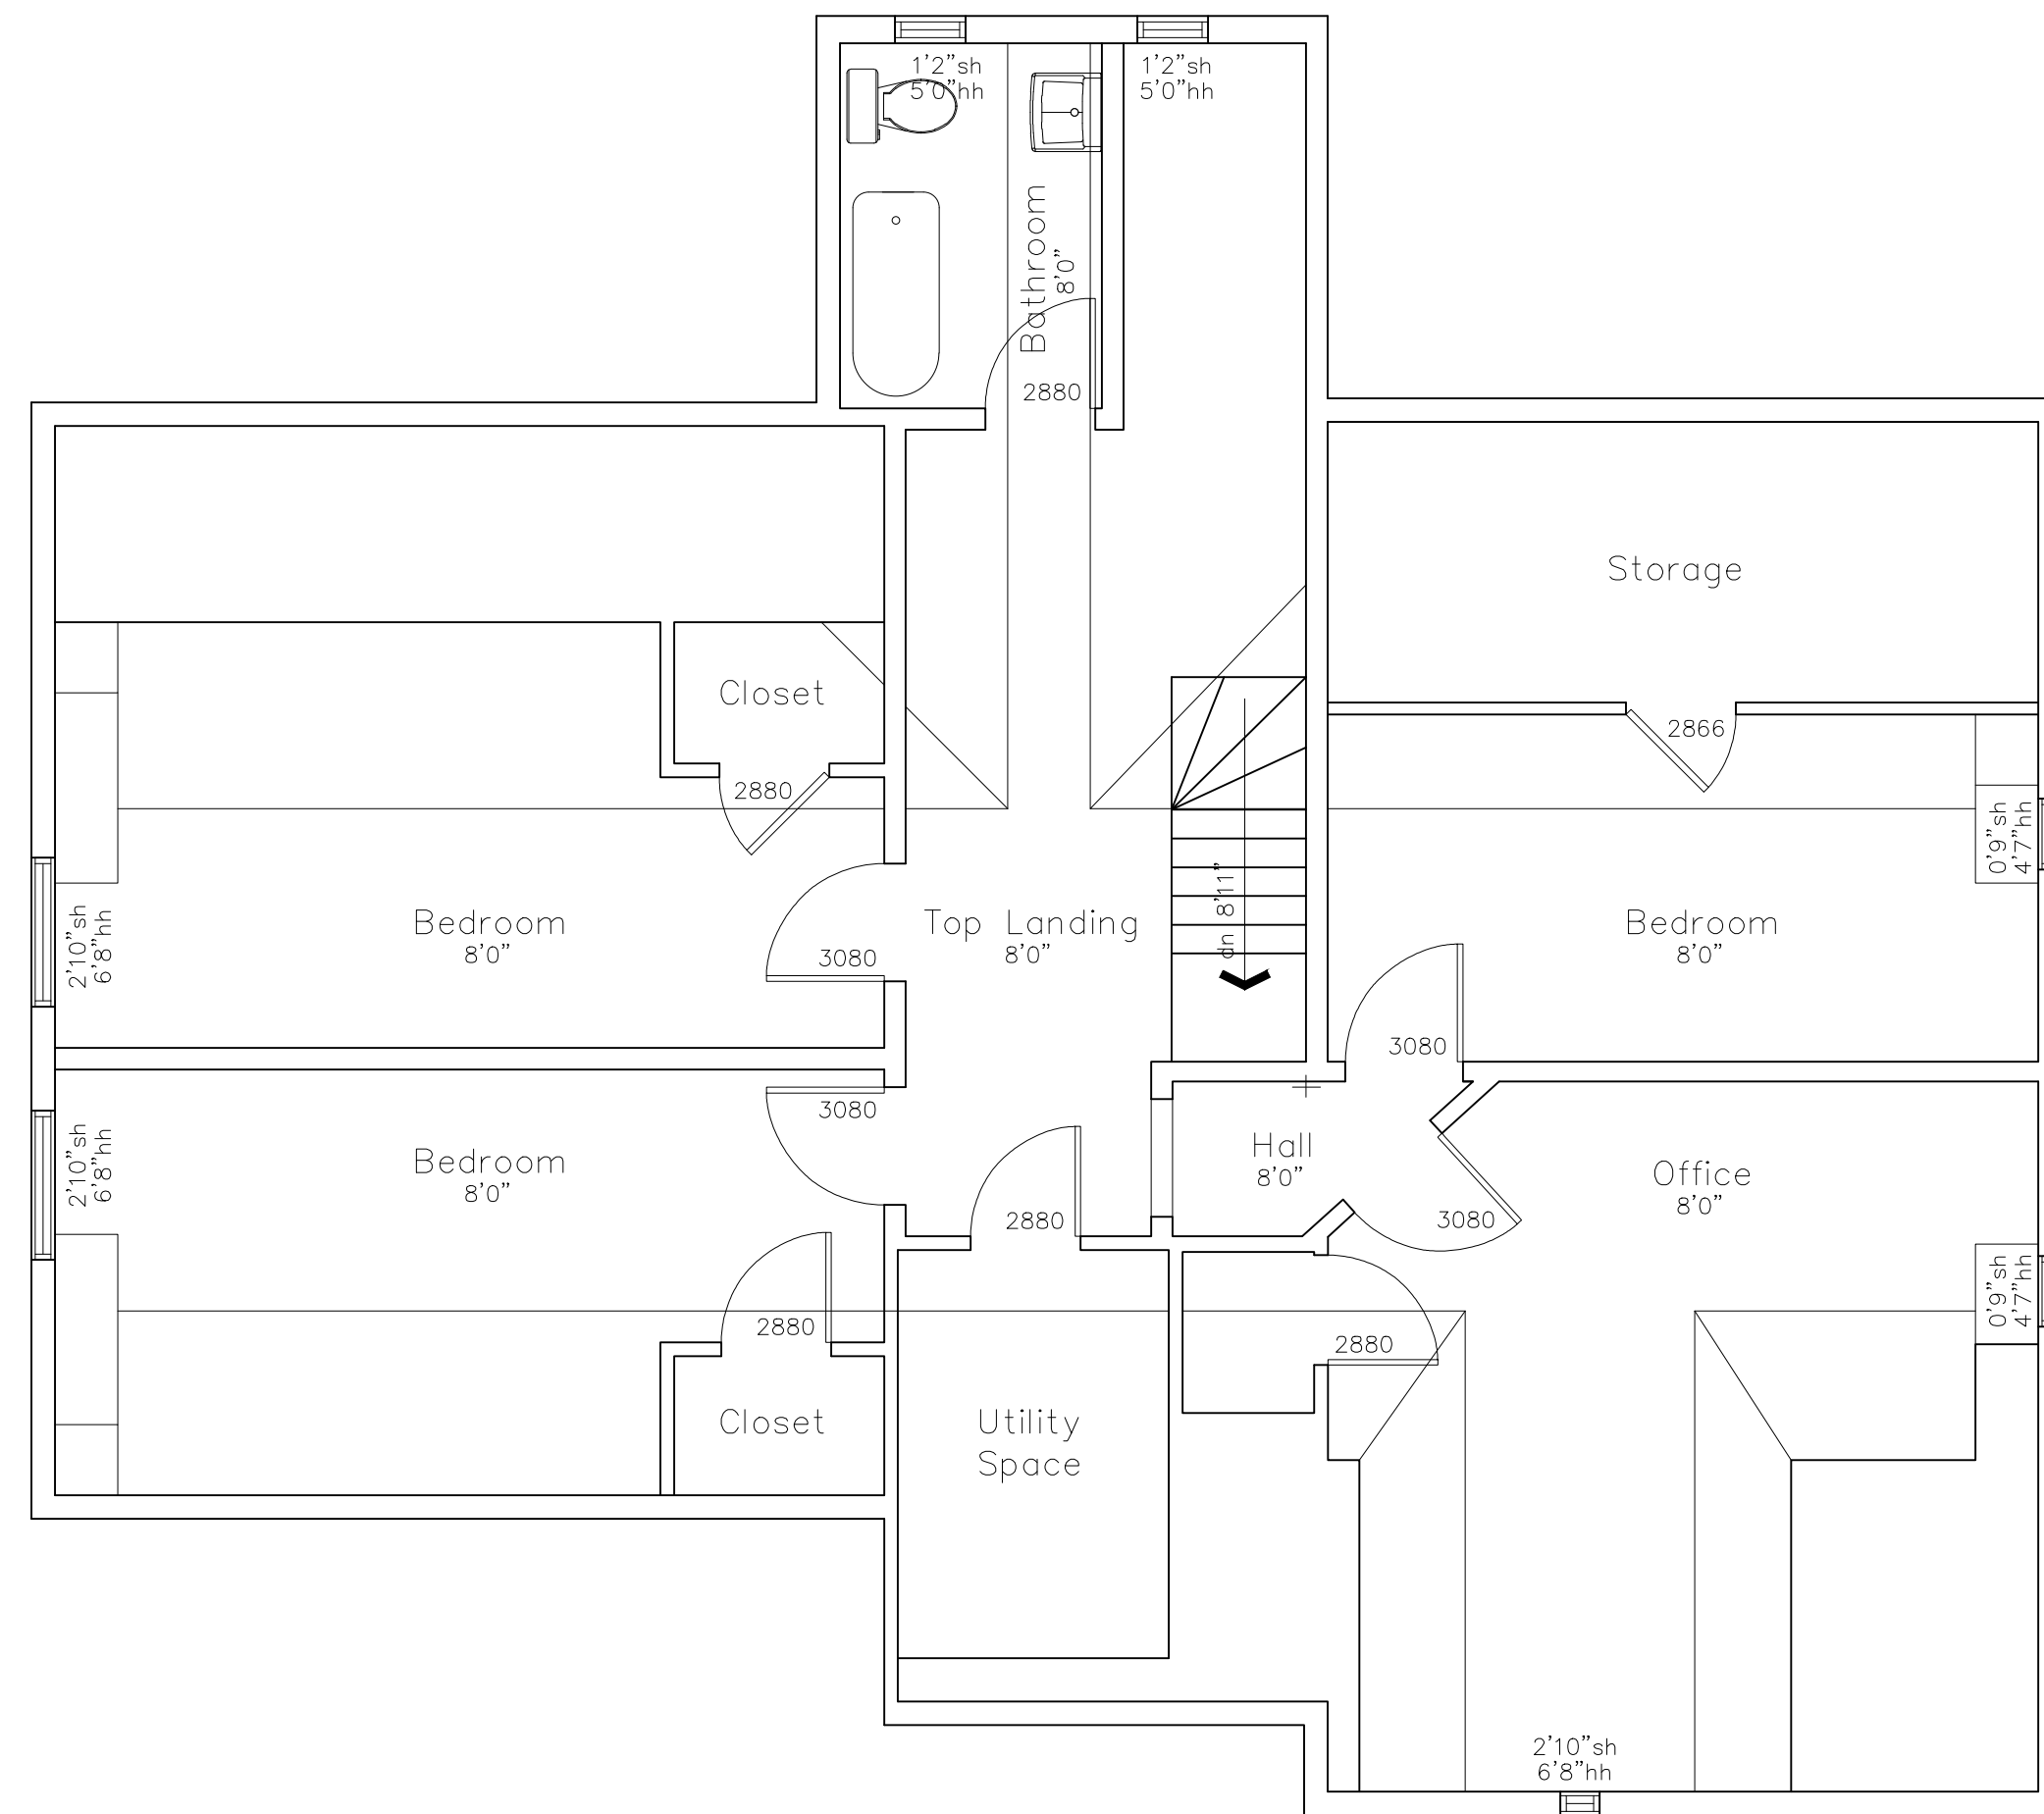

ARCHITECTURAL AS BUILT

01	100% SUBMISSION	
NO.	ISSUES REVISIONS	DATE
		SHEET TITLE
H/L	PROJECT MANAGER	
H/L	PROJECT DIRECTOR	
012317-1		PROJECT NUMBER
1/4"=1'-0"		SCALE
CL	DRAWN BY	
		SHEET NUMBER



SPECIFIC SPOT ELEV DIMENSION.
DIMENSION REQUESTED BY ARCHITECT: DRIVEWAY GRADE AT REAR HOUSE POINT.



ARCHITECTURAL AS BUILT

Ridgewood, NJ 07450

01	100% SUBMISSION	
NO.	ISSUES REVISIONS	DATE
		SHEET TITLE
HL		PROJECT MANAGER
HL		PROJECT DIRECTOR
012317-1		PROJECT NUMBER
1/4"=1'-0"		SCALE
CL		DRAWN BY

AB-5



RIGHT SIDE ELEVATION

LEFT SIDE ELEVATION

As BUILT

PROFESSIONALS

www.asbuiltprofessionals.com

A DIVISION OF:

AEC

CONSULTANTS INC

844.272.8458

844 AS BUILT

© 2019 AEC CONSULTANTS INC

ARCHITECTURAL AS BUILT

Ridgewood, NJ 07450

01	100% SUBMISSION	
NO.	ISSUES REVISIONS	DATE
		SHEET TITLE
HL		PROJECT MANAGER
HL		PROJECT DIRECTOR
012317-1		PROJECT NUMBER
1/8"=1'-0"		SCALE
CL		DRAWN BY
		SHEET NUMBER
AB-6		

