

AS-BUILT DOCUMENTATION


ROYAL OAK MI



100% SUBMITTAL

DRAWING INDEX

- C-1 COVER SHEET | DRAWING INDEX
- SL SYMBOLS LEGEND
- AB-1 BASEMENT PLAN
- AB-2 FIRST FLOOR PLAN
- AB-3 SECOND FLOOR PLAN
- AB-4 FRONT / RIGHT SIDE ELEVATION
- AB-5 REAR / LEFT SIDE ELEVATION

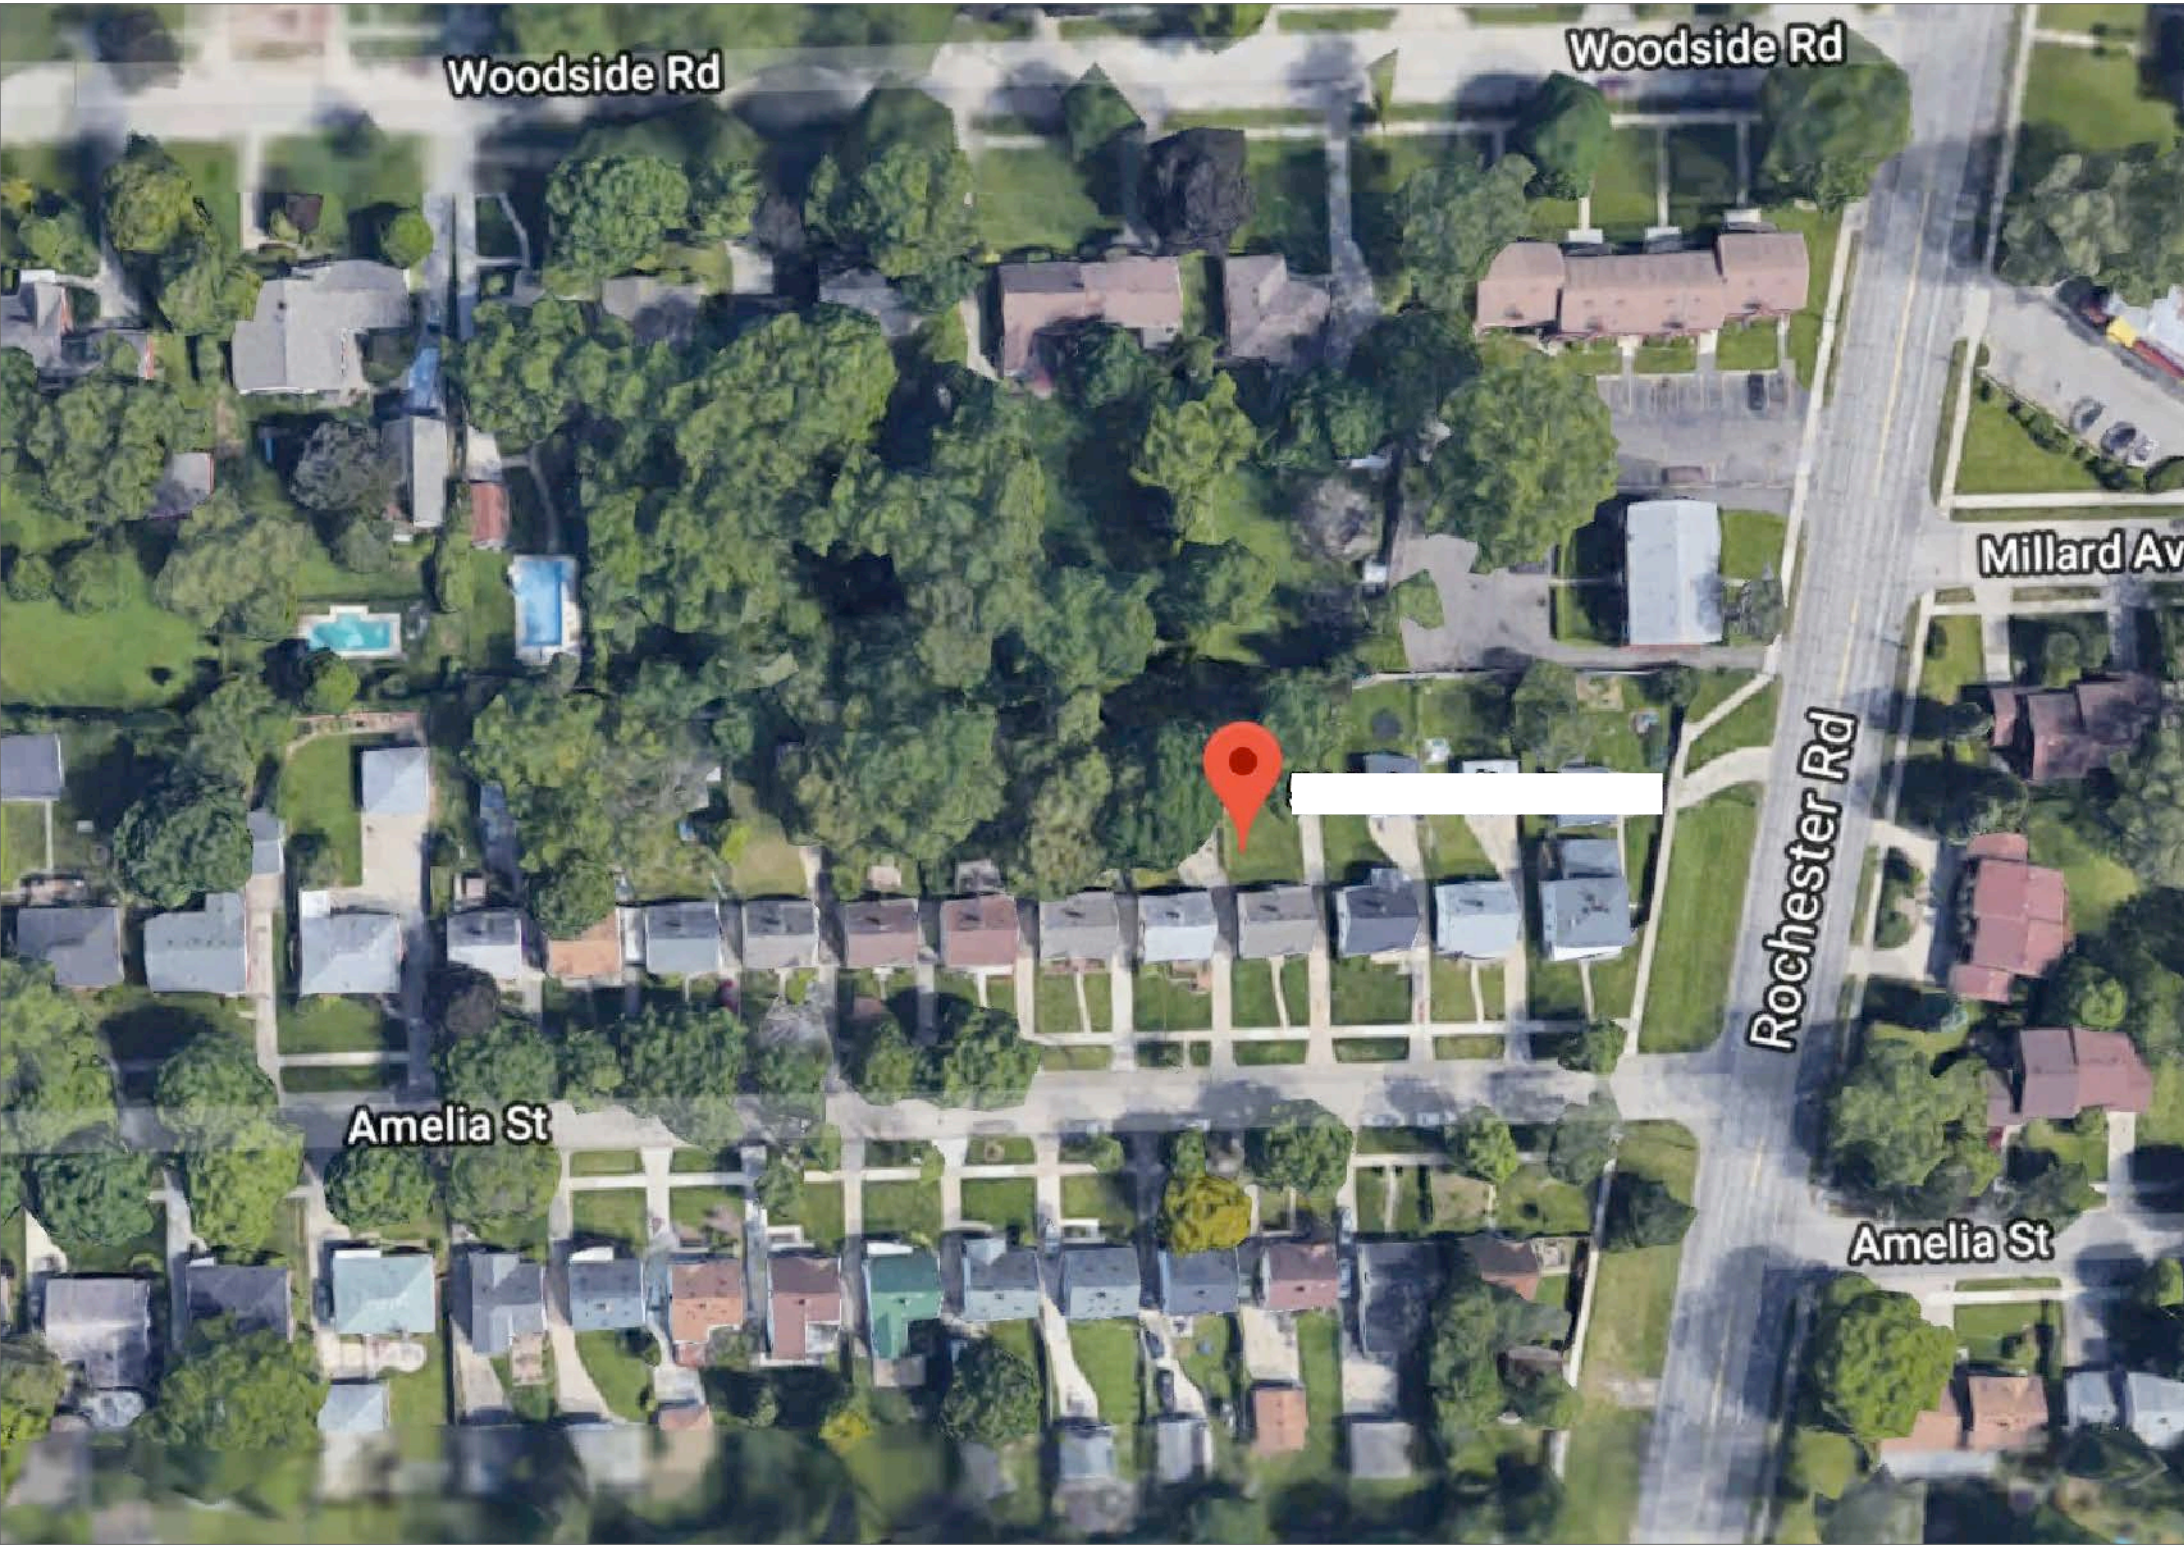

VICINITY MAP NTS

AREA DATA	
LIVING BASEMENT	649 S.F. ±
LIVING FIRST FLOOR	716 S.F. ±
LIVING SECOND FLOOR	315 S.F. ±
SECOND FLOOR STORAGE	0 S.F. ±
SCREEN ROOM	0 S.F. ±
DECKS	85 S.F. ±
GARAGE	0 S.F. ±
ENTRY	0 S.F. ±
TOTAL LIVING	1680 S.F. ±
GRAND TOTAL	1765 S.F. ±

AS BUILT

PROFESSIONALS

www.asbuiltprofessionals.com

A DIVISION OF:

AEC

CONSULTANTS INC

844.272.8458

844 AS BUILT

© 2019 AEC CONSULTANTS INC

ARCHITECTURAL AS BUILT Royal Oak MI

01	100% SUBMISSION	SEE COVER SHEET
NO.	ISSUES REVISIONS	DATE
		SHEET TITLE
COVER SHEET		
HL	PROJECT MANAGER	
HL	PROJECT DIRECTOR	
012317-1	PROJECT NUMBER	
	SCALE	
CL	DRAWN BY	
	SHEET NUMBER	

C-1

SYMBOLS LEGEND

RCP

	EXHAUST VENT		TRACK LIGHT OR VANITY LIGHT
	CEILING MOUNTED LIGHT FIXTURE		WALL-MOUNTED LIGHT FIXTURE
	CEILING MOUNTED DIRECTIONAL LIGHT		EMERGENCY EXIT SIGN
	RECESSED CAN LIGHT		EMERGENCY EXIT LIGHT
	EYEBALL OR SMALL CAN LIGHT		EMERGENCY EXIT LIGHT W/ SIGN
	PENDANT LIGHT		LIGHTED STAIR SIGN
	INDIVIDUAL FLUOR. LAY-IN FIXTURE 4 BULB		FLOOD LIGHT
	INDIVIDUAL FLUOR. HANGING FIXTURE 2 BULB		PHOTO CELL
	INDIVIDUAL FLUOR. FLUSH MOUNT FIXTURE 4 BULB		CEILING FAN
	CAMERA		CEILING FAN W/ LIGHT KIT
	MOTION DET.	<p>7-2-6</p>	CEILING HEIGHT AND TRIM 7'-2" ABOVE FLOOR BELOW WITH 6" CROWN MOULDING. NOTE: ALL CEILINGS NOT LABELED ARE PLASTER. CEILINGS SHOWN WITH A GRID ARE LAY IN ACOUSTICAL TILE..
	SUPPLY VENT		JUNCTION BOX
	SUPPLY VENT		
	RETURN VENT		
	RETURN VENT		
	SPEAKER		

ELECTRIC

	DATA OUTLET
	TELEPHONE JACK
	ELECTRIC SWITCH
	CABLE TELEVISION OUTLET
	DUPLEX RECEPTACLE OUTLET
	SPECIAL PURPOSE CONNECTION OR OUTLET
	QUADRUPLUX RECEPTACLE OUTLET
	FLOOR DUPLEX RECEPTACLE OUTLET
	ELECTRIC PANEL
	ELECTRIC METER
	BUTTON SWITCH
	DISCONNECT SWITCH
	GROUND/FLOOR LIGHT
	KEY PAD

FIRE PROTECTION


	FIRE EXTINGUISHER
	FIRE PULL
	FIRE ALARM (HORN/SRTOBE)
	SMOKE DETECTOR
	SMOKE ALARM SPEAKER
	SPRINKLER HEAD CEILING MOUNT
	SPRINKLER HEAD WALL MOUNT

MEP


	THERMOSTAT
	FLOOR DRAIN
	VALVE
	HOSE BIB
	WATER SUPPLY
	SUSPENDED GAS HEATER

MISC


	BOLLARD
	SPOT ELEVATION

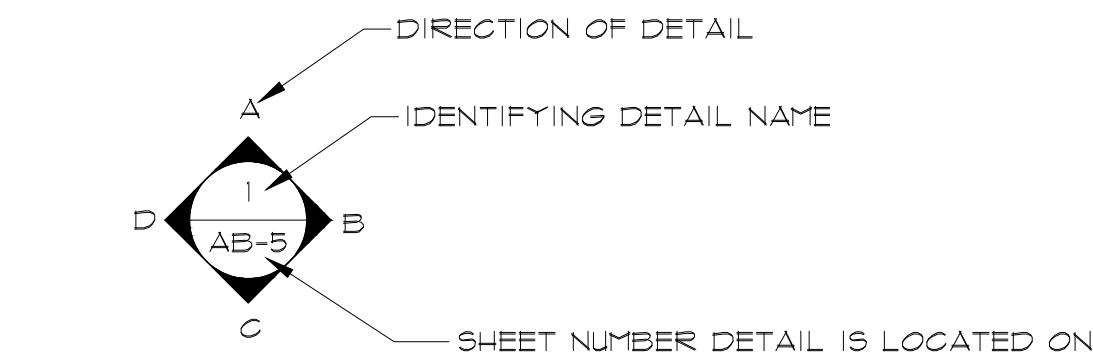

INTERIOR ELEVATIONS

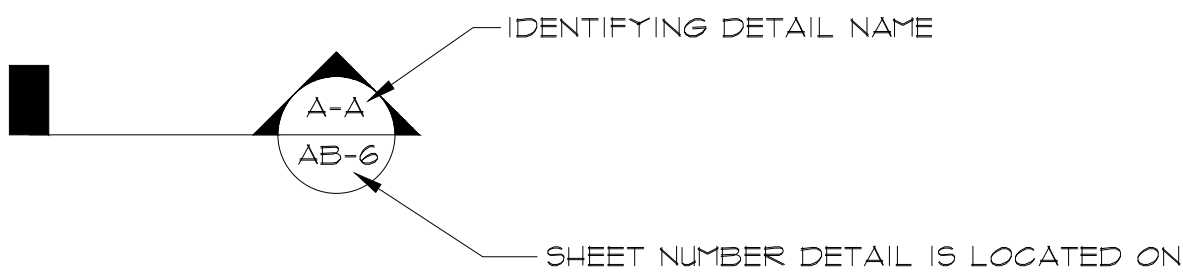

BUILDING SECTION

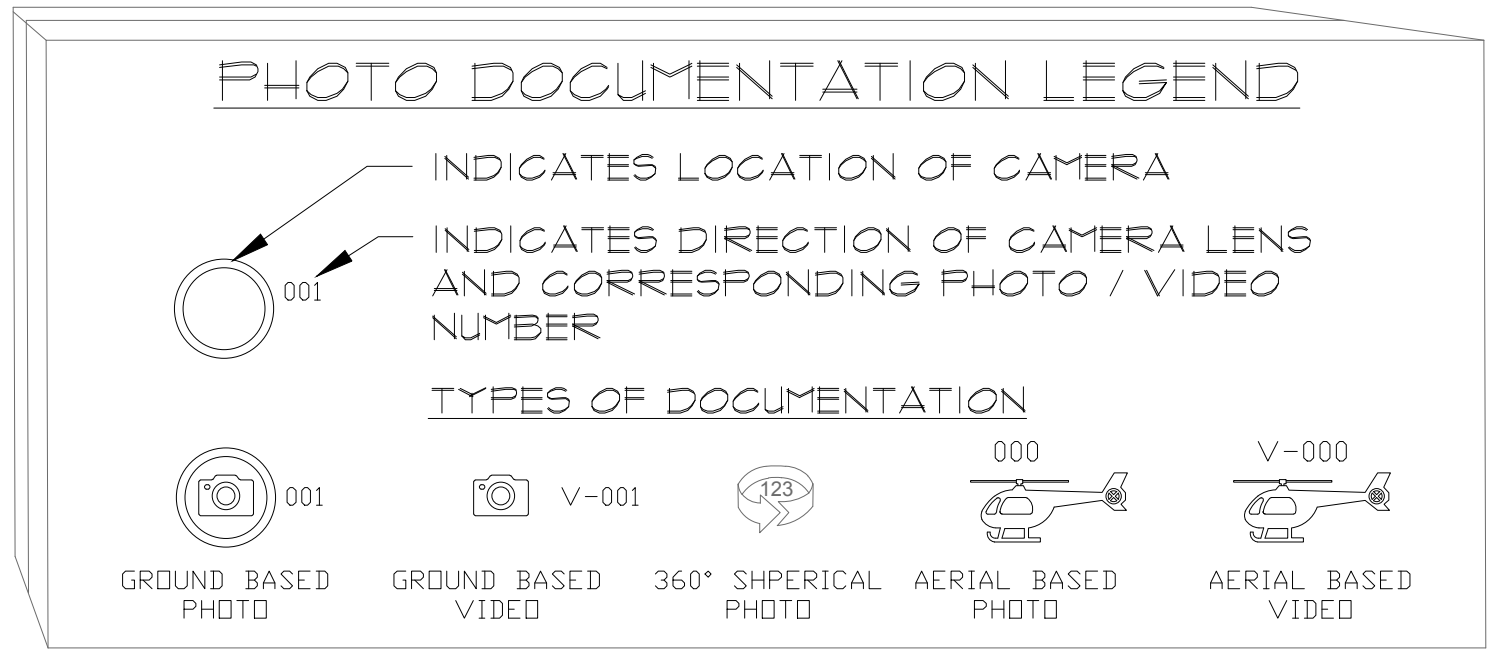

As BUILT
PROFESSIONALS
www.asbuiltprofessionals.com
A DIVISION OF:


AEC
CONSULTANTS INC
844.272.8458
844 AS BUILT

© 2019 AEC CONSULTANTS INC

ARCHITECTURAL AS BUILT
Royal Oak MI

01	100% SUBMISSION	SEE COVER SHEET
NO.	ISSUES REVISIONS	DATE
		SHEET TITLE
HL		PROJECT MANAGER
HL		PROJECT DIRECTOR
012317-1		PROJECT NUMBER
NOT TO SCALE		SCALE
CL		DRAWN BY
		SHEET NUMBER

SL

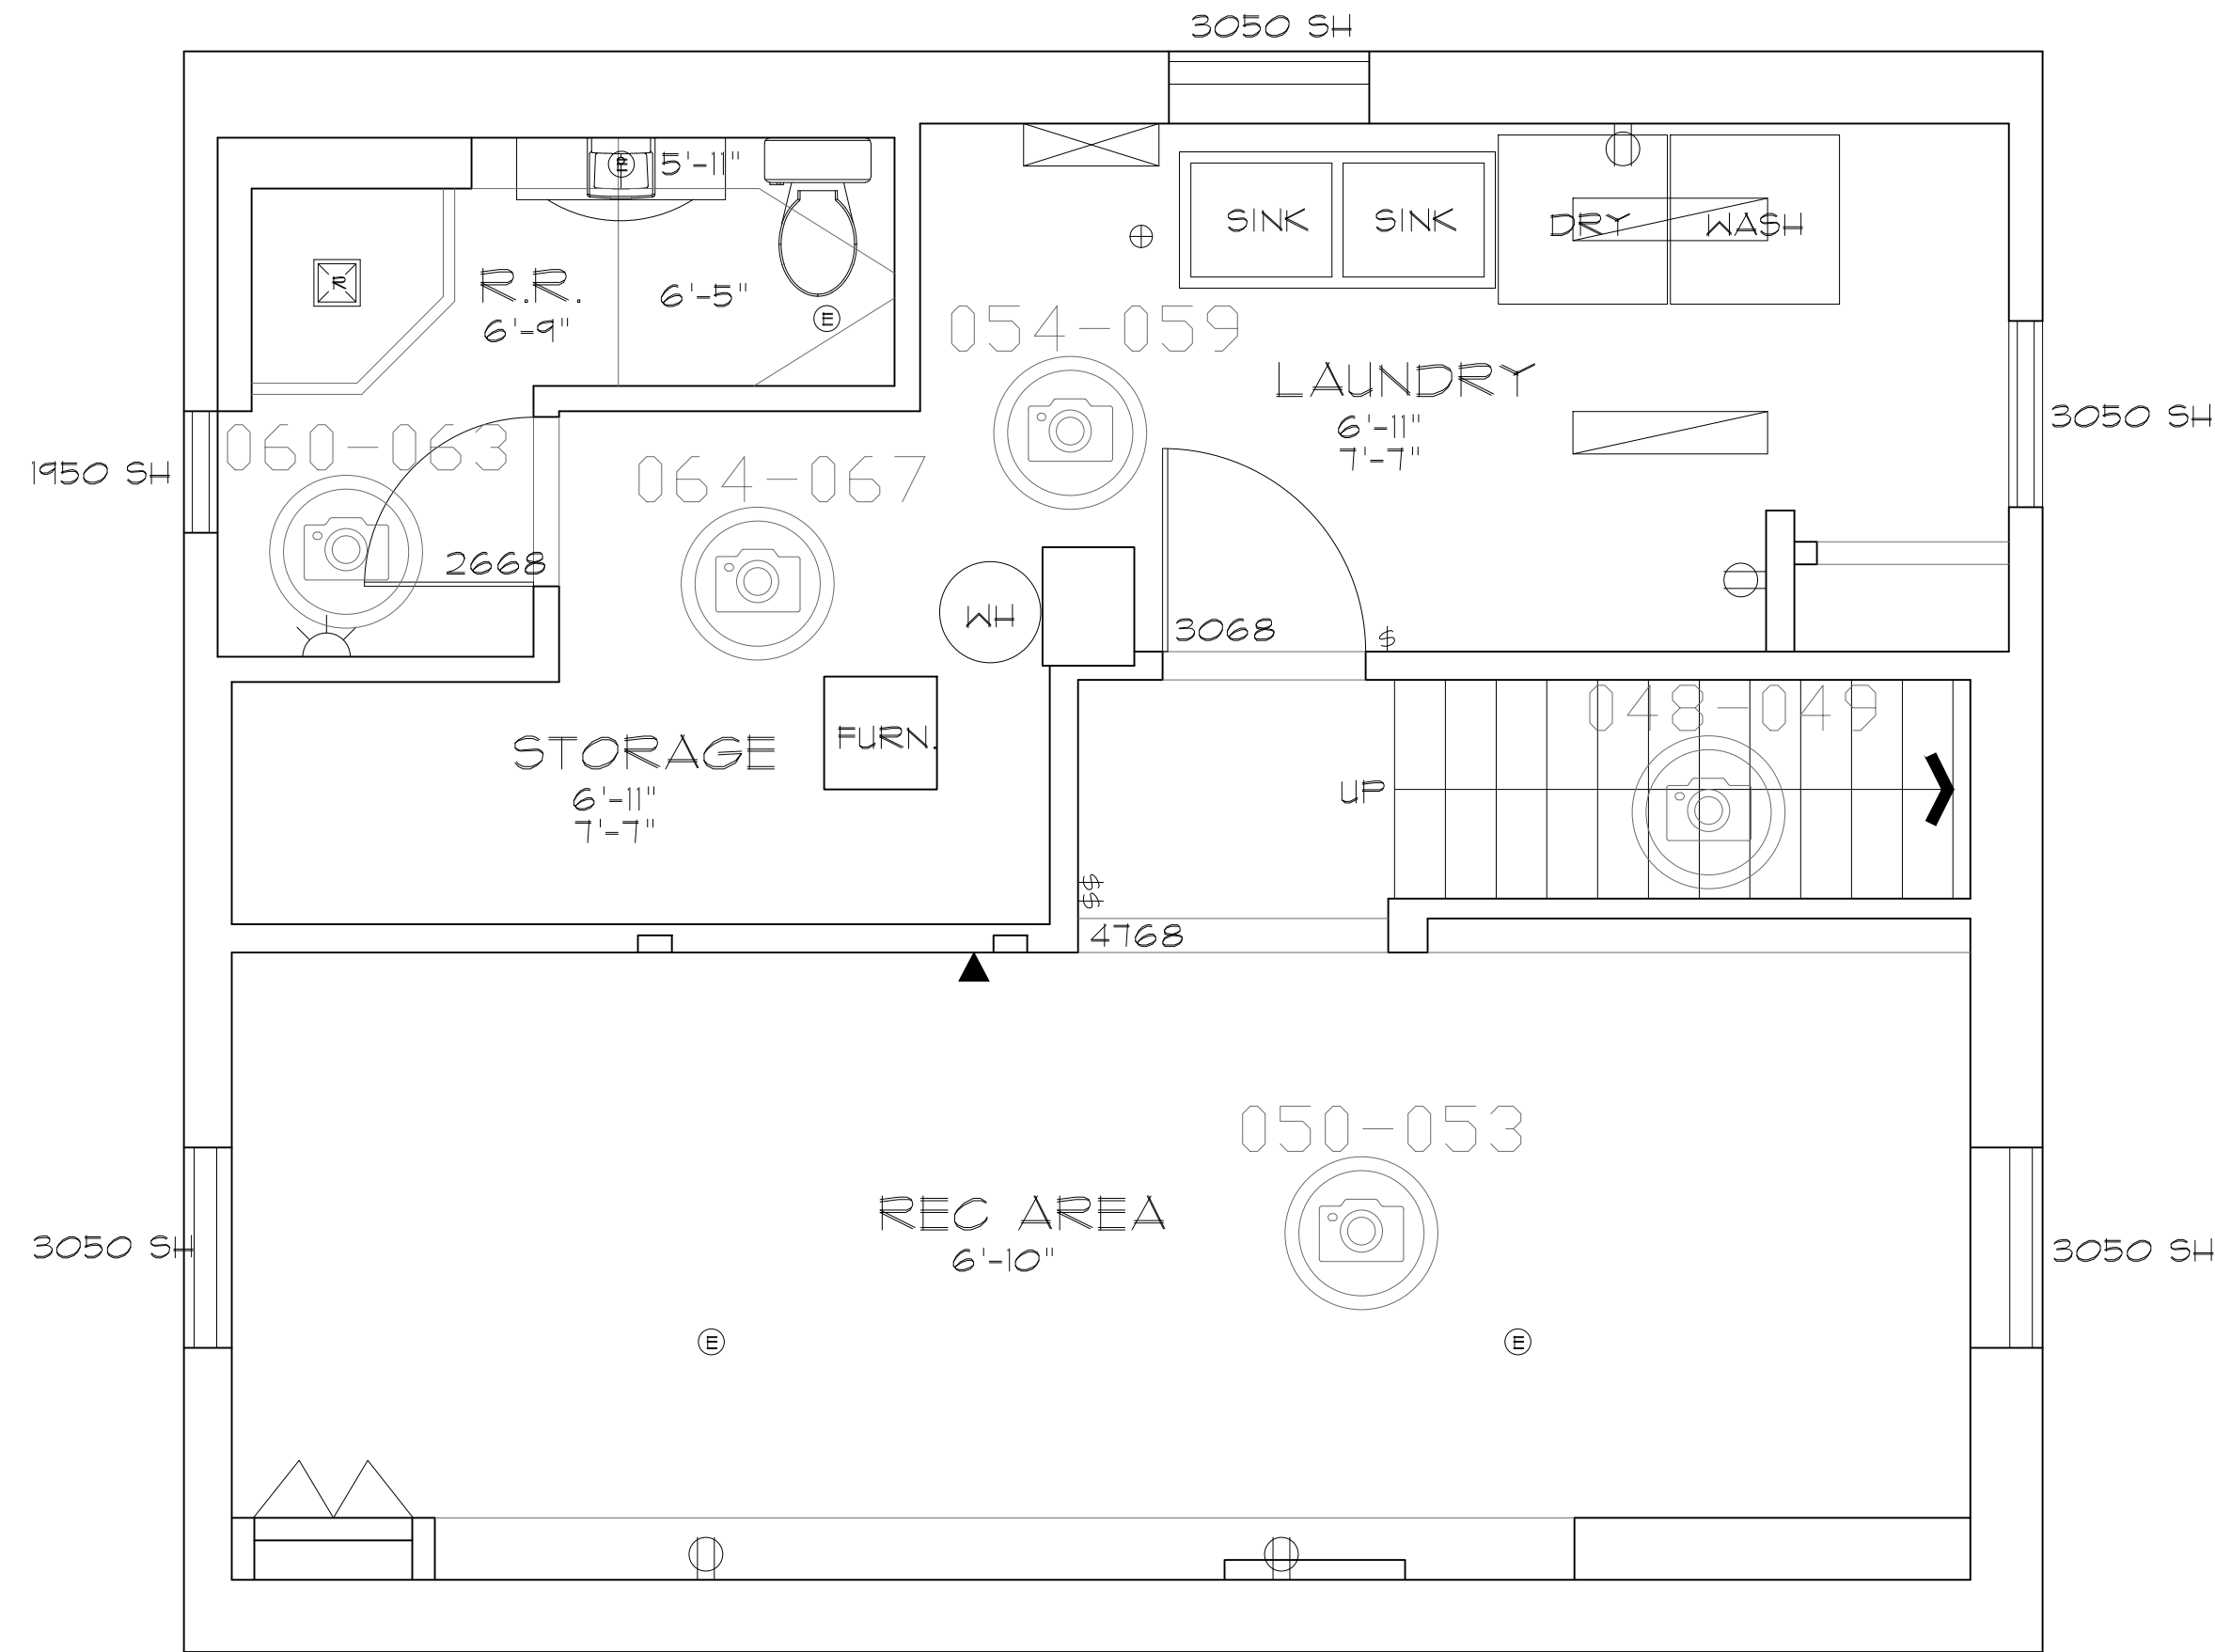

BASEMENT FLOOR PLAN

As BUILT

PROFESSIONALS

www.asbuiltprofessionals.com

A DIVISION OF:

AEC

CONSULTANTS INC

844.272.8458

844 AS BUILT

@ 2019 AEC CONSULTANTS INC

ARCHITECTURAL AS BUILT

Royal Oak MI


01	100% SUBMISSION	SEE COVER SHEET
NO.	ISSUES REVISIONS	DATE
SHEET TITLE		
HL	PROJECT MANAGER	
HL	PROJECT DIRECTOR	
012317-1	PROJECT NUMBER	
3/8"=1'-0"	SCALE	
CL	DRAWN BY	
SHEET NUMBER		

AB-1



01	100% SUBMISSION	SEE COVER SHEET
NO.	ISSUES REVISIONS	DATE
		SHEET TITLE
HL		PROJECT MANAGER
HL		PROJECT DIRECTOR
012317-1		PROJECT NUMBER
3/8"=1'-0"		SCALE
CL		DRAWN BY
		SHEET NUMBER


AB-2

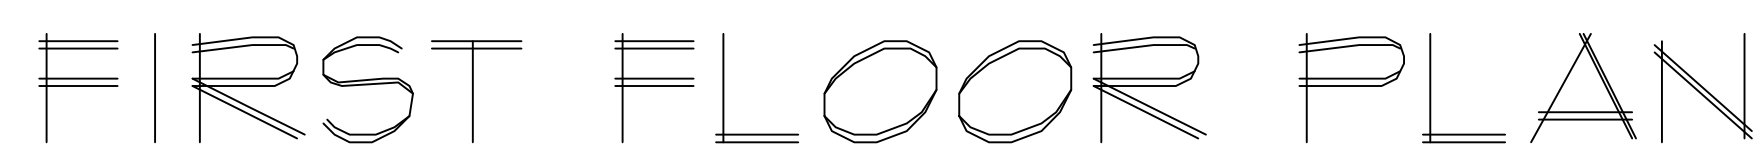




01	100% SUBMISSION	SEE COVER SHEET
NO.	ISSUES REVISIONS	DATE
		SHEET TITLE
HL		PROJECT MANAGER
HL		PROJECT DIRECTOR
012317-1		PROJECT NUMBER
3/8"=1'-0"		SCALE
CL		DRAWN BY
		SHEET NUMBER

AB-3

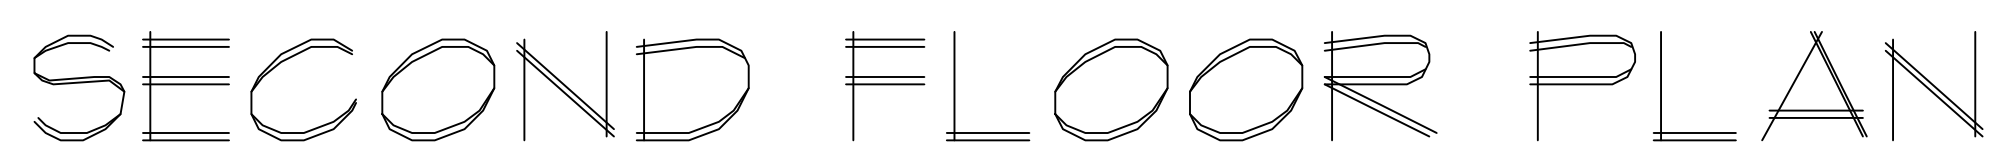

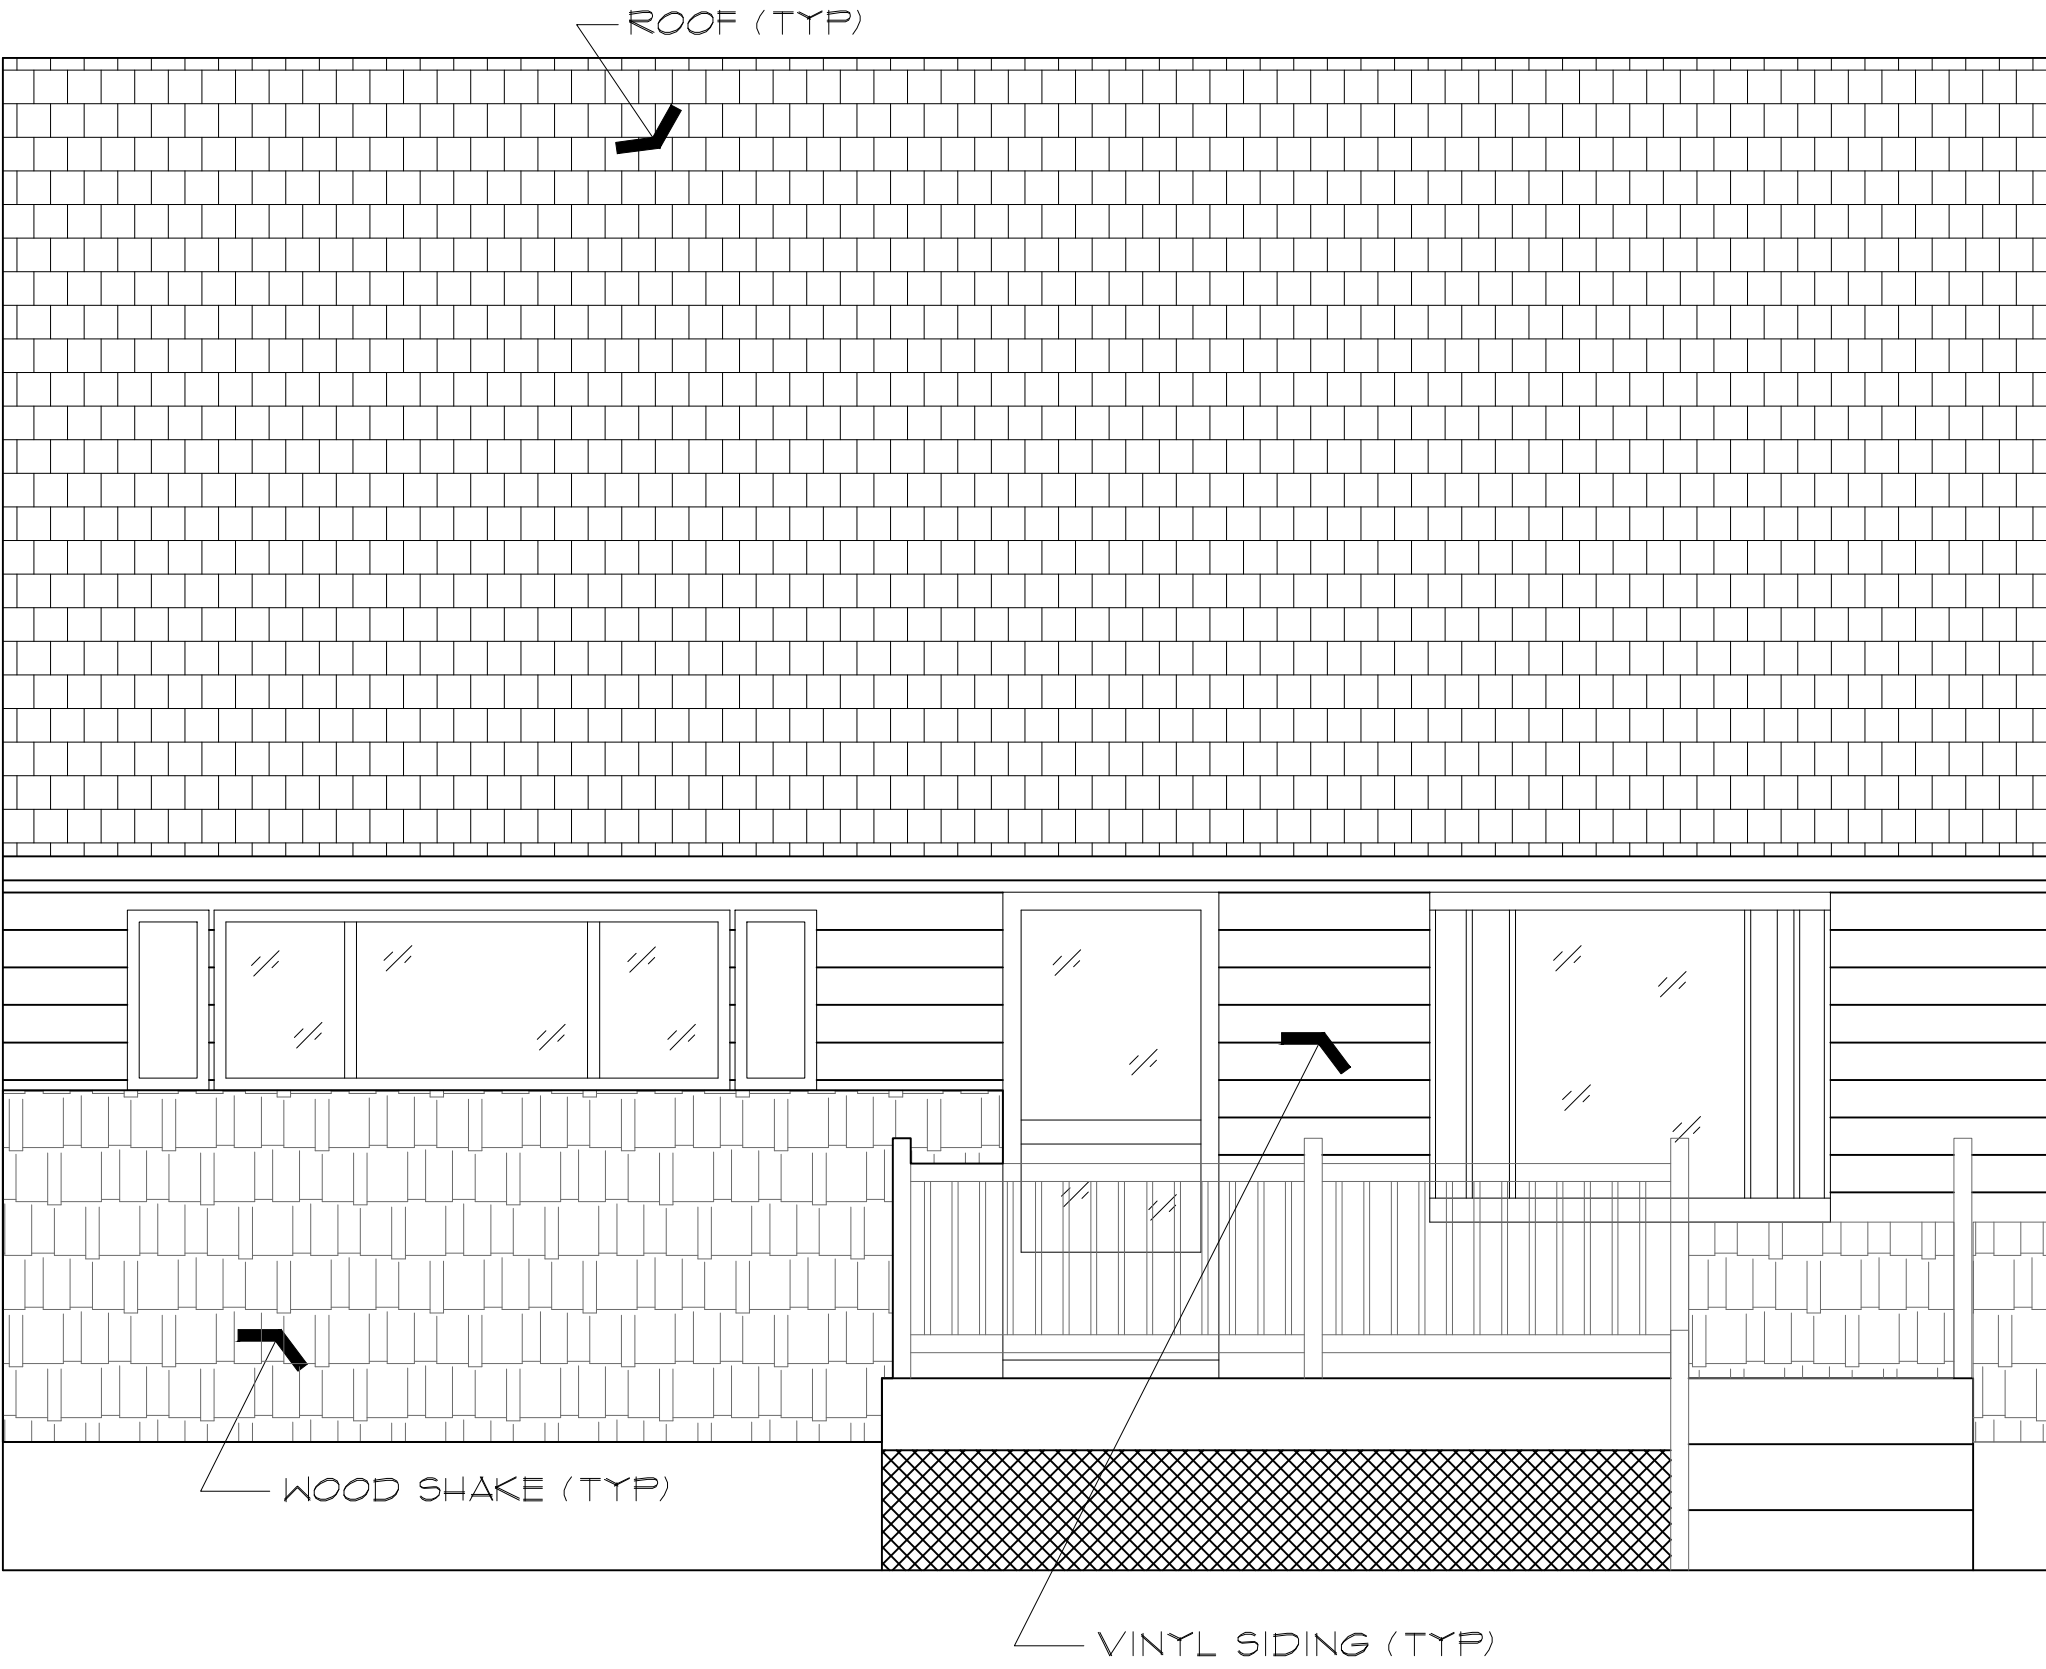

FRONT ELEVATION



RIGHT ELEVATION

As BUILT

PROFESSIONALS

www.asbuiltprofessionals.com

A DIVISION OF:

AEC

CONSULTANTS INC


844.272.8458

844 AS BUILT

@ 2019 AEC CONSULTANTS INC

ARCHITECTURAL AS BUILT
Royal Oak MI

01	100% SUBMISSION	SEE COVER SHEET
NO.	ISSUES REVISIONS	DATE
		SHEET TITLE
HL		PROJECT MANAGER
HL		PROJECT DIRECTOR
012317-1		PROJECT NUMBER
3/8"=1'-0"		SCALE
CL		DRAWN BY
		SHEET NUMBER
AB-4		

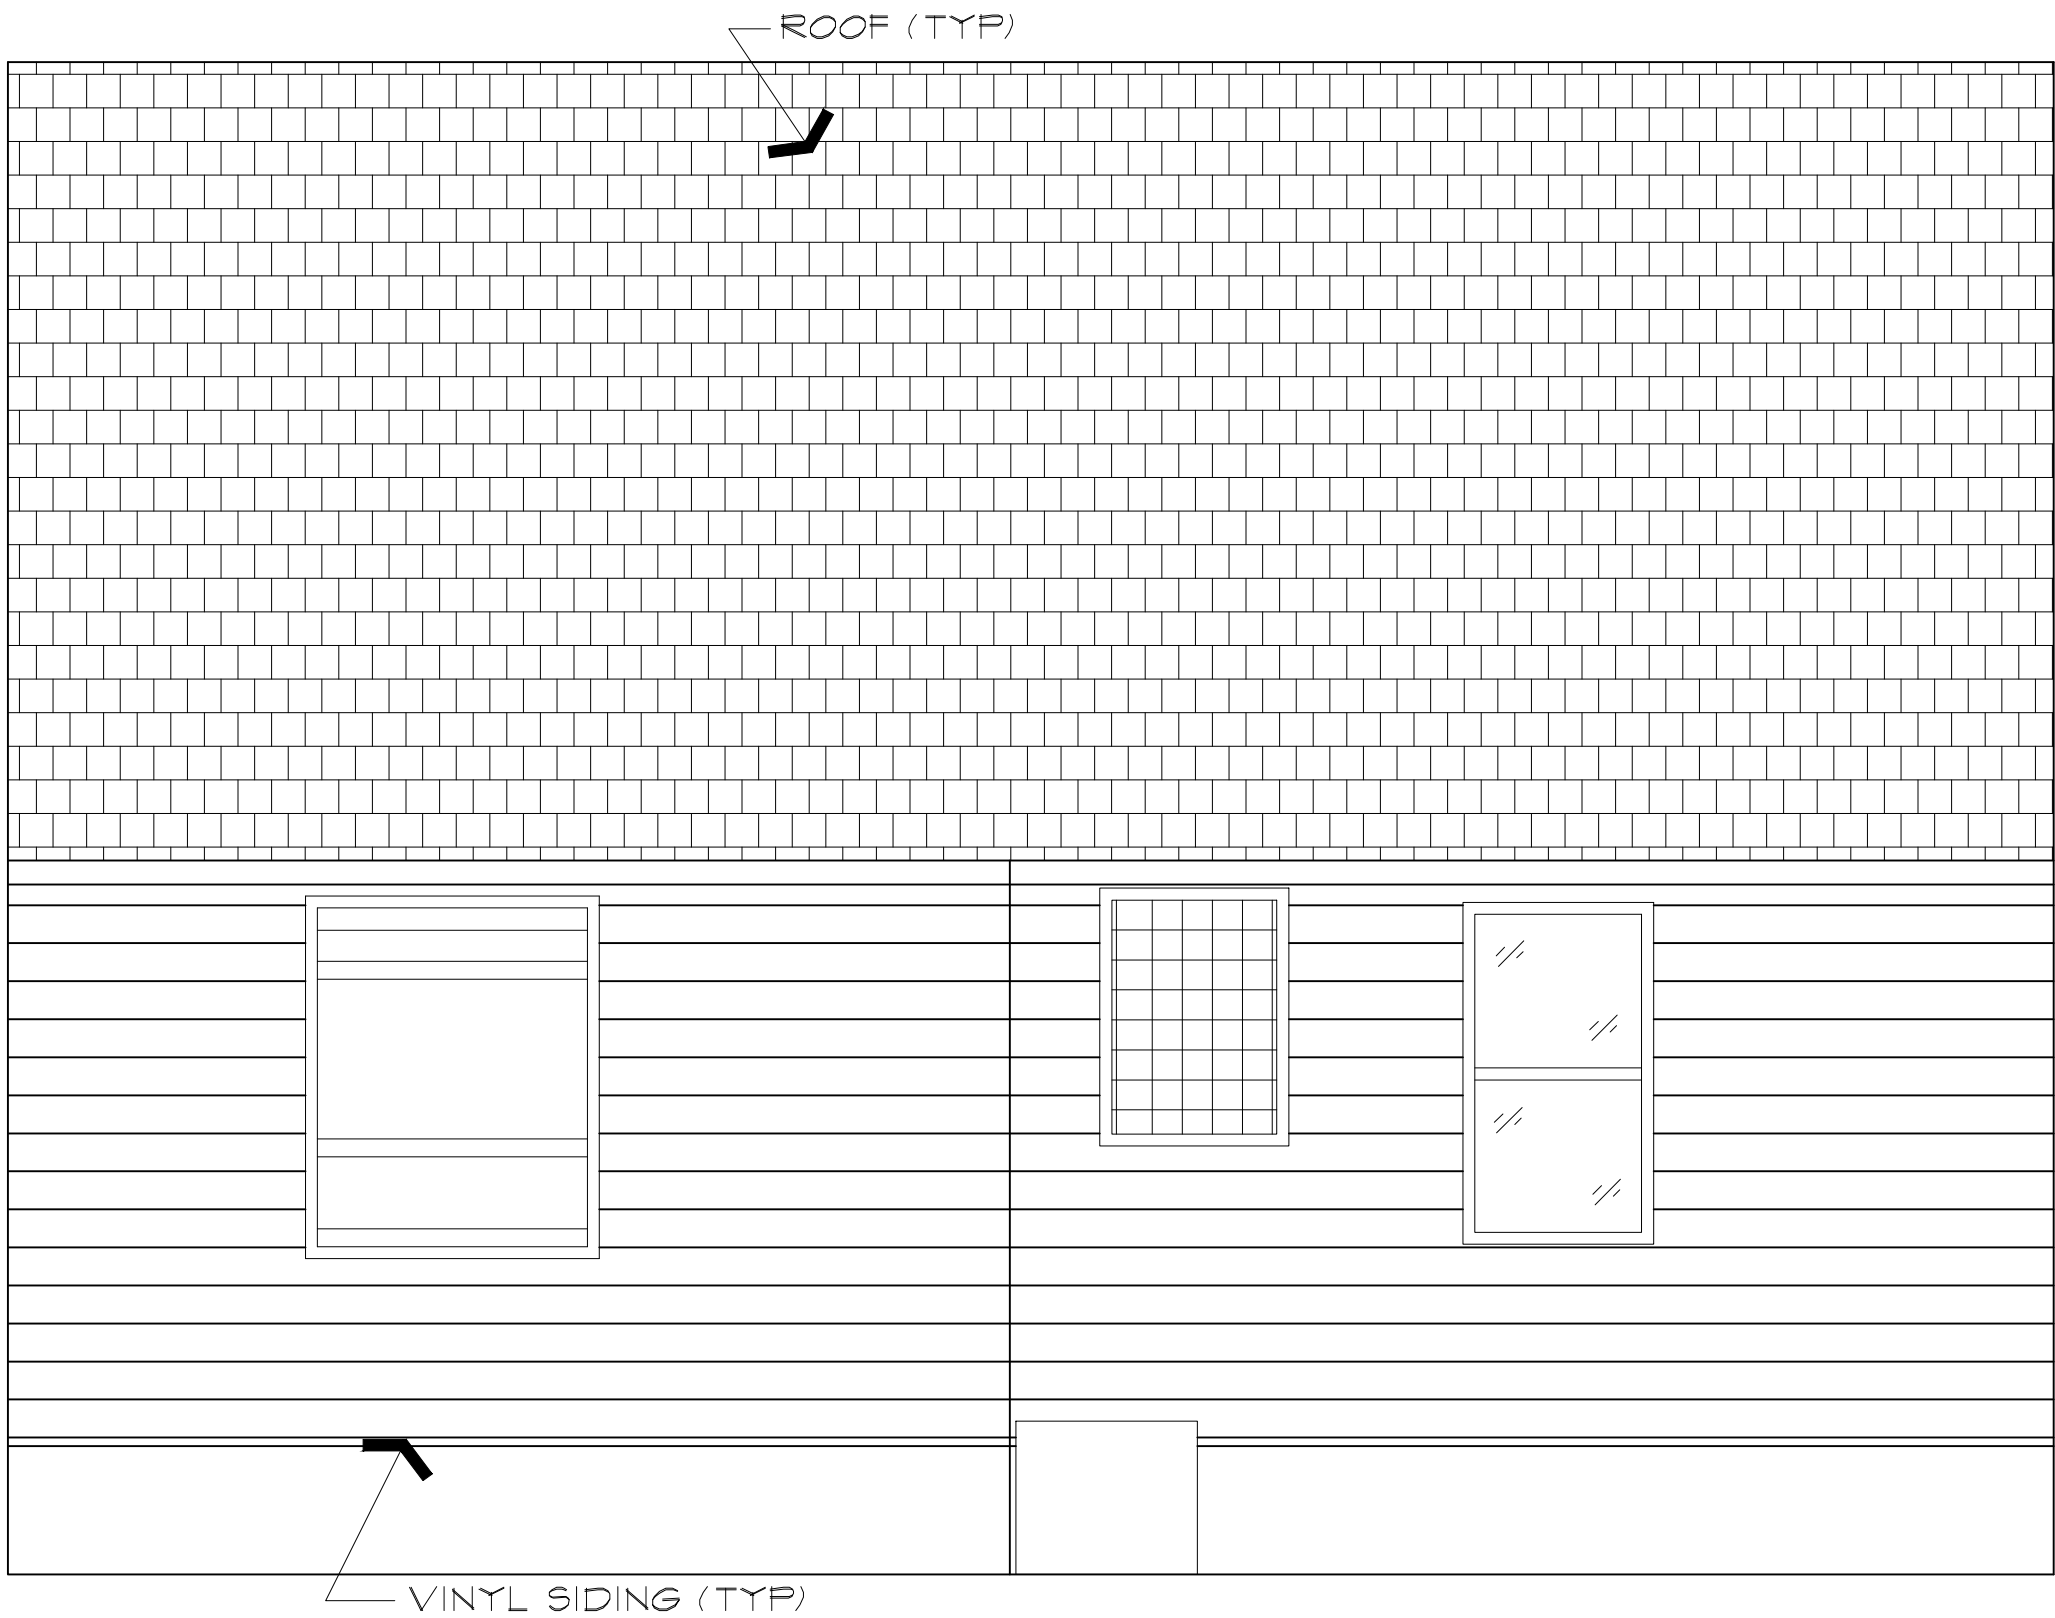

REAR ELEVATION



LEFT ELEVATION

As BUILT

PROFESSIONALS

www.asbuiltprofessionals.com

A DIVISION OF:

AEC

CONSULTANTS INC

844.272.8458

844 AS BUILT

@ 2019 AEC CONSULTANTS INC

ARCHITECTURAL AS BUILT

Royal Oak MI

01	100% SUBMISSION	SEE COVER SHEET
NO.	ISSUES REVISIONS	DATE
		SHEET TITLE
HL		PROJECT MANAGER
HL		PROJECT DIRECTOR
012317-1		PROJECT NUMBER
3/8"=1'-0"		SCALE
CL		DRAWN BY
		SHEET NUMBER