

AS-BUILT DOCUMENTATION

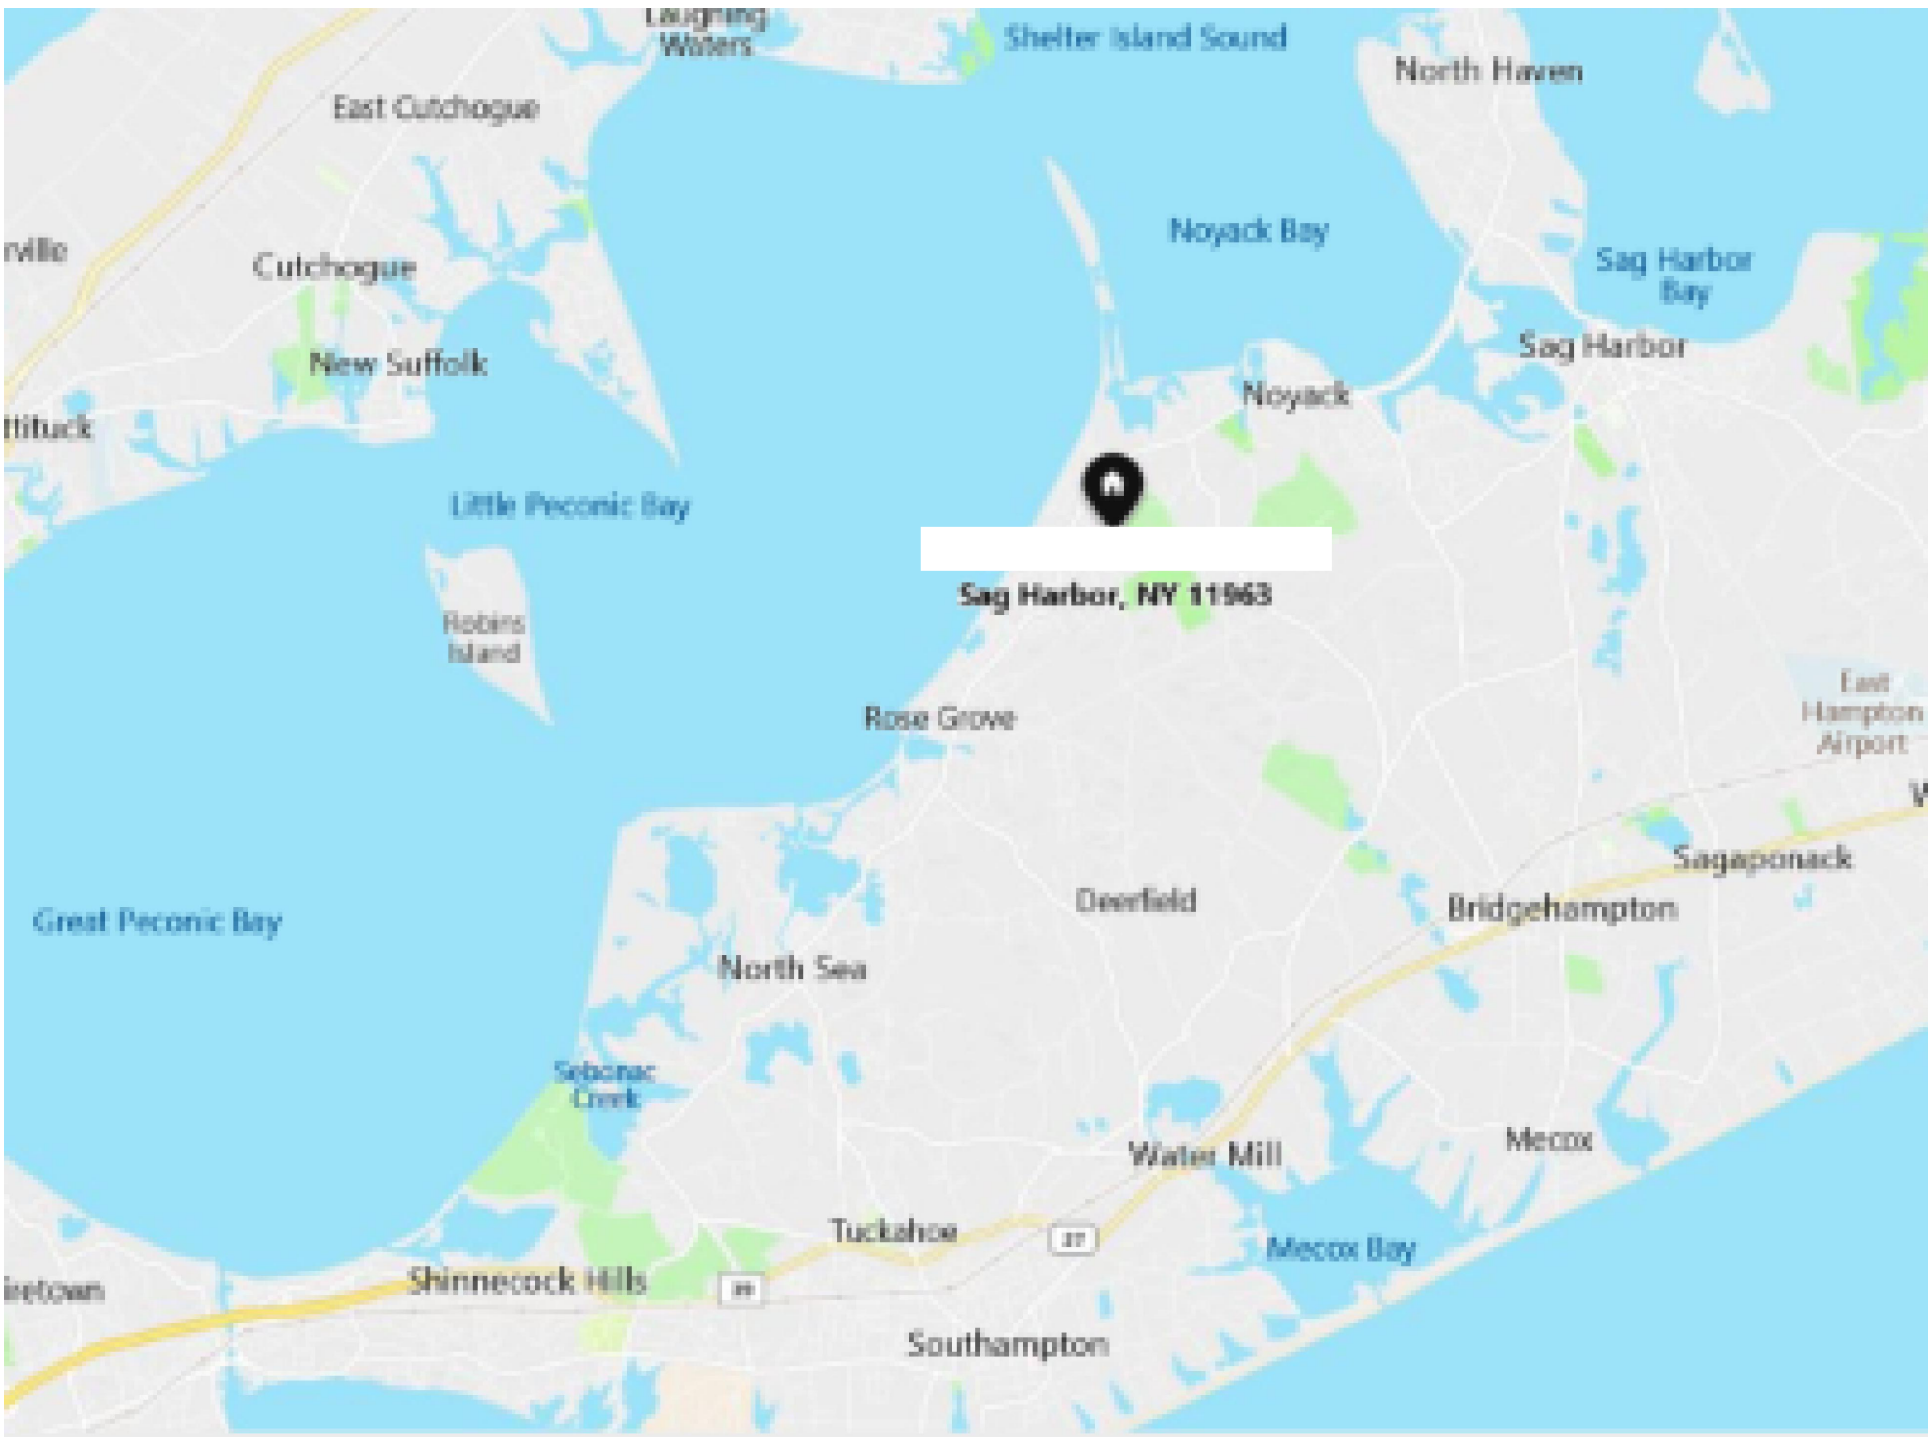
Sag Harbor, NY 11963



100% SUBMITTAL

DRAWING INDEX

- C-1 COVER SHEET | DRAWING INDEX
- SL SYMBOLS LEGEND
- AB-1 POOL HOUSE AND ROOF PLAN
- AB-2 MAIN HOUSE AND ROOF PLAN
- AB-3 POOL HOUSE EXTERIORS
- AB-4 POOL HOUSE INTERIORS
- AB-5 MAIN HOUSE EXTERIORS
- AB-6 MAIN HOUSE INTERIORS



VICINITY MAP NTS

AREA DATA	
HOME FIRST FLOOR	2,149 S.F. ±
HOME SECOND FLOOR	590 S.F. ±
HOME TOTAL	2,739 S.F. ±
POOL HOUSE	557 S.F. ±
GRAND TOTAL	3,296 S.F. ±

As BUILT

PROFESSIONALS

www.asbuiltprofessionals.com

A DIVISION OF:

AEC

CONSULTANTS INC

844.272.8458

844 A S BUILT

© 2017 AEC CONSULTANTS INC

ARCHITECTURAL AS BUILT











Sag Harbor, NY 11963










01	100% SUBMISSION	
NO.	ISSUES REVISIONS	DATE
SHEET TITLE		
COVER SHEET		
HL	PROJECT MANAGER	
HL	PROJECT DIRECTOR	
012317-1	PROJECT NUMBER	
	SCALE	
CL	DRAWN BY	
	SHEET NUMBER	

C-1

SYMBOLS LEGEND

  
 
 
 
 
 
 
 
 
RCP

         -  EXHAUST VENT
-  CEILING MOUNTED LIGHT FIXTURE
-  CEILING MOUNTED DIRECTIONAL LIGHT
-  RECESSED CAN LIGHT
-  EYEBALL OR SMALL CAN LIGHT
-  PENDANT LIGHT
-  INDIVIDUAL FLUOR. LAY-IN FIXTURE 4 BULB
-  INDIVIDUAL FLUOR. HANGING FIXTURE 2 BULB
-  INDIVIDUAL FLUOR. FLUSH MOUNT FIXTURE 4 BULB
-  CAMERA
-  MOTION DET.
-  SUPPLY VENT
-  SUPPLY VENT
-  RETURN VENT
-  RETURN VENT
-  SPEAKER




-  TRACK LIGHT OR VANITY LIGHT
-  WALL-MOUNTED LIGHT FIXTURE
-  EMERGENCY EXIT SIGN
-  EMERGENCY EXIT LIGHT
-  EMERGENCY EXIT LIGHT W/ SIGN
-  LIGHTED STAIR SIGN
-  FLOOD LIGHT
-  PHOTO CELL
-  CEILING FAN
-  CEILING FAN W/ LIGHT KIT
-  JUNCTION BOX

7-2-6 CEILING HEIGHT AND TRIM 7'-2" ABOVE FLOOR BELOW WITH 6" CROWN MOULDING. NOTE: ALL CEILINGS NOT LABELED ARE PLASTER. CEILINGS SHOWN WITH A GRID ARE LAY IN ACOUSTICAL TILE..

        
 
ELECTRIC

-  DATA OUTLET
-  TELEPHONE JACK
-  ELECTRIC SWITCH
-  CABLE TELEVISION OUTLET
-  DUPLEX RECEPTACLE OUTLET
-  SPECIAL PURPOSE CONNECTION OR OUTLET
-  QUADRUPLX RECEPTACLE OUTLET
-  FLOOR DUPLEX RECEPTACLE OUTLET
-  ELECTRIC PANEL
-  ELECTRIC METER
-  BUTTON SWITCH
-  DISCONNECT SWITCH
-  GROUND/FLOOR LIGHT
-  KEY PAD

   FIRE PROTECTION

-  FIRE EXTINGUISHER
-  FIRE PULL
-  FIRE ALARM (HORN/SRTOBE)
-  SMOKE DETECTOR
-  SMOKE ALARM SPEAKER
-  SPRINKLER HEAD CEILING MOUNT
-  SPRINKLER HEAD WALL MOUNT

  MEP

-  THERMOSTAT
-  FLOOR DRAIN
-  VALVE
-  HOSE BIB
-  WATER SUPPLY
-  SUSPENDED GAS HEATER

MISC


 
 
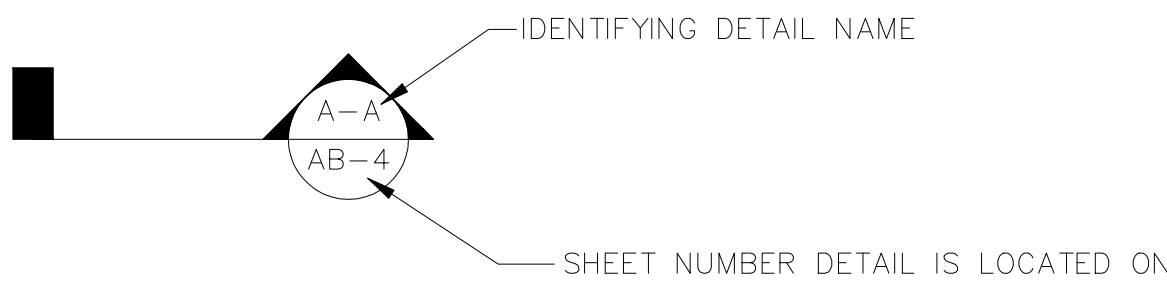
-  BOLLARD
-  11-4-11/16 SPOT ELEVATION

PHOTO DOCUMENTATION LEGEND

-  INDICATES LOCATION OF CAMERA
-  INDICATES DIRECTION OF CAMERA LENS AND CORRESPONDING PHOTO / VIDEO NUMBER
-  TYPES OF DOCUMENTATION
-  GROUND BASED VIDEO
-  360° SHPERICAL PHOTO
-  AERIAL BASED PHOTO
-  AERIAL BASED VIDEO

7-2-6

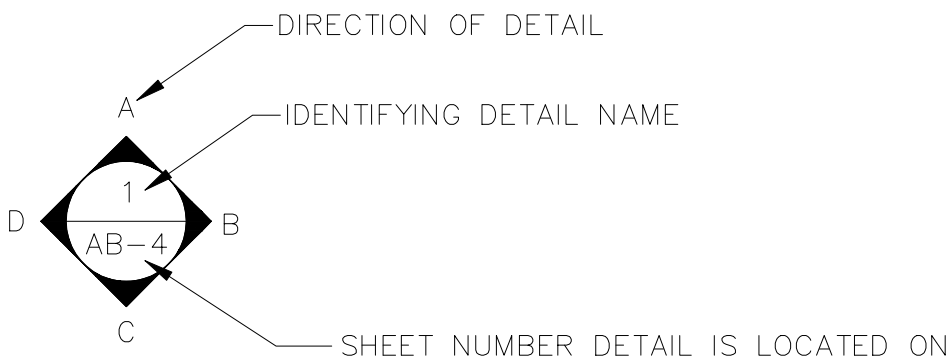CEILING HEIGHT AND TRIM 7'-2" ABOVE FLOOR BELOW WITH 6" CROWN MOULDING. NOTE: ALL CEILINGS NOT LABELED ARE PLASTER. CEILINGS SHOWN WITH A GRID ARE LAY IN ACOUSTICAL TILE..





As BUILT
PROFESSIONALS
www.asbuiltprofessionals.com
A DIVISION OF:




AEC
CONSULTANTS INC
844.272.8458
844 AS BUILT

© 2017 AEC CONSULTANTS INC




ARCHITECTURAL AS BUILT
Sag Harbor, NY 11963

01	100% SUBMISSION		
NO.	ISSUES REVISIONS		DATE
			SHEET TITLE
HL	PROJECT MANAGER		
HL	PROJECT DIRECTOR		
012317-1			PROJECT NUMBER
NOT TO SCALE			SCALE
CL	DRAWN BY		
			SHEET NUMBER

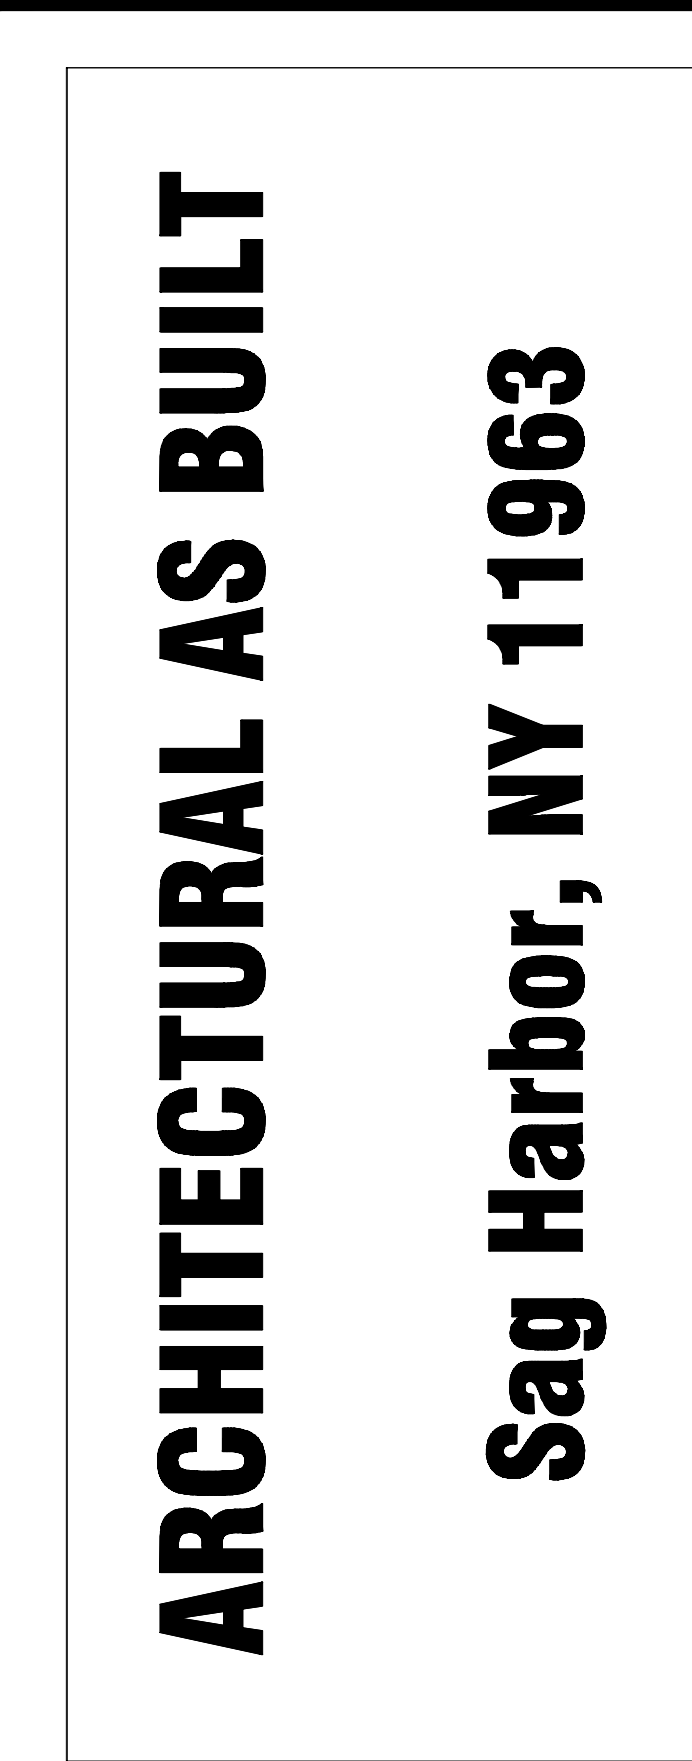SL

[illegible]

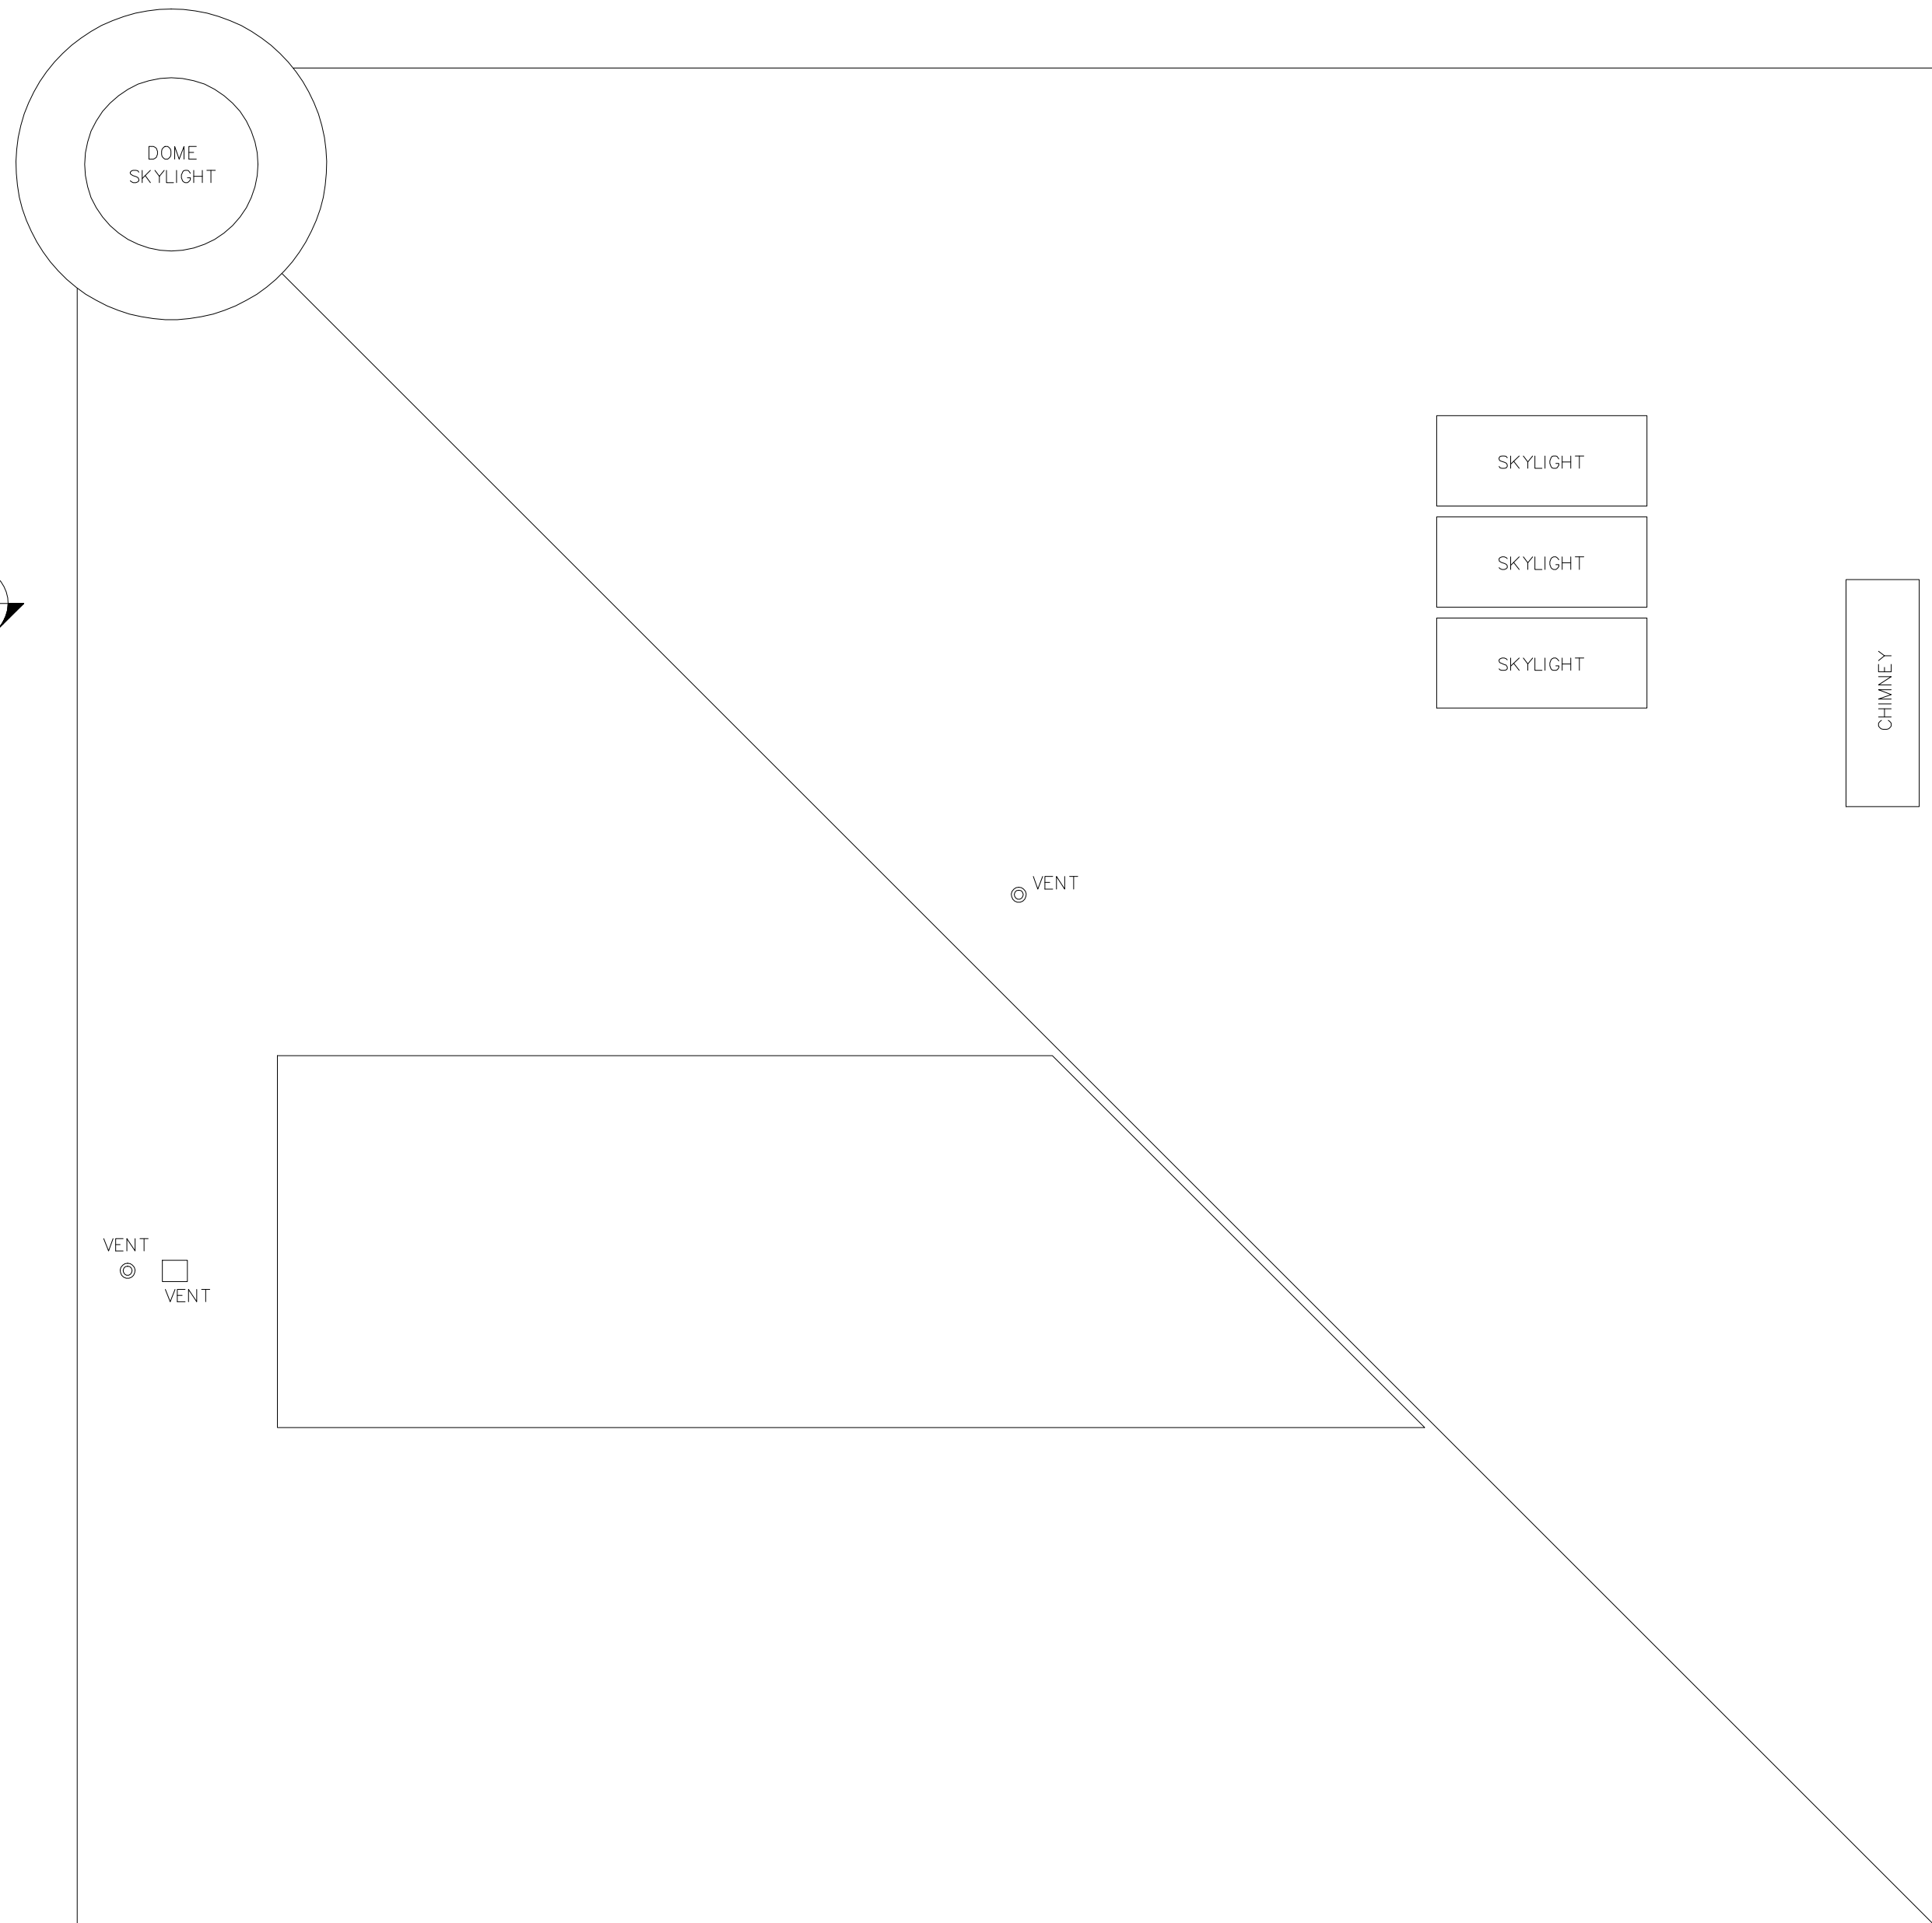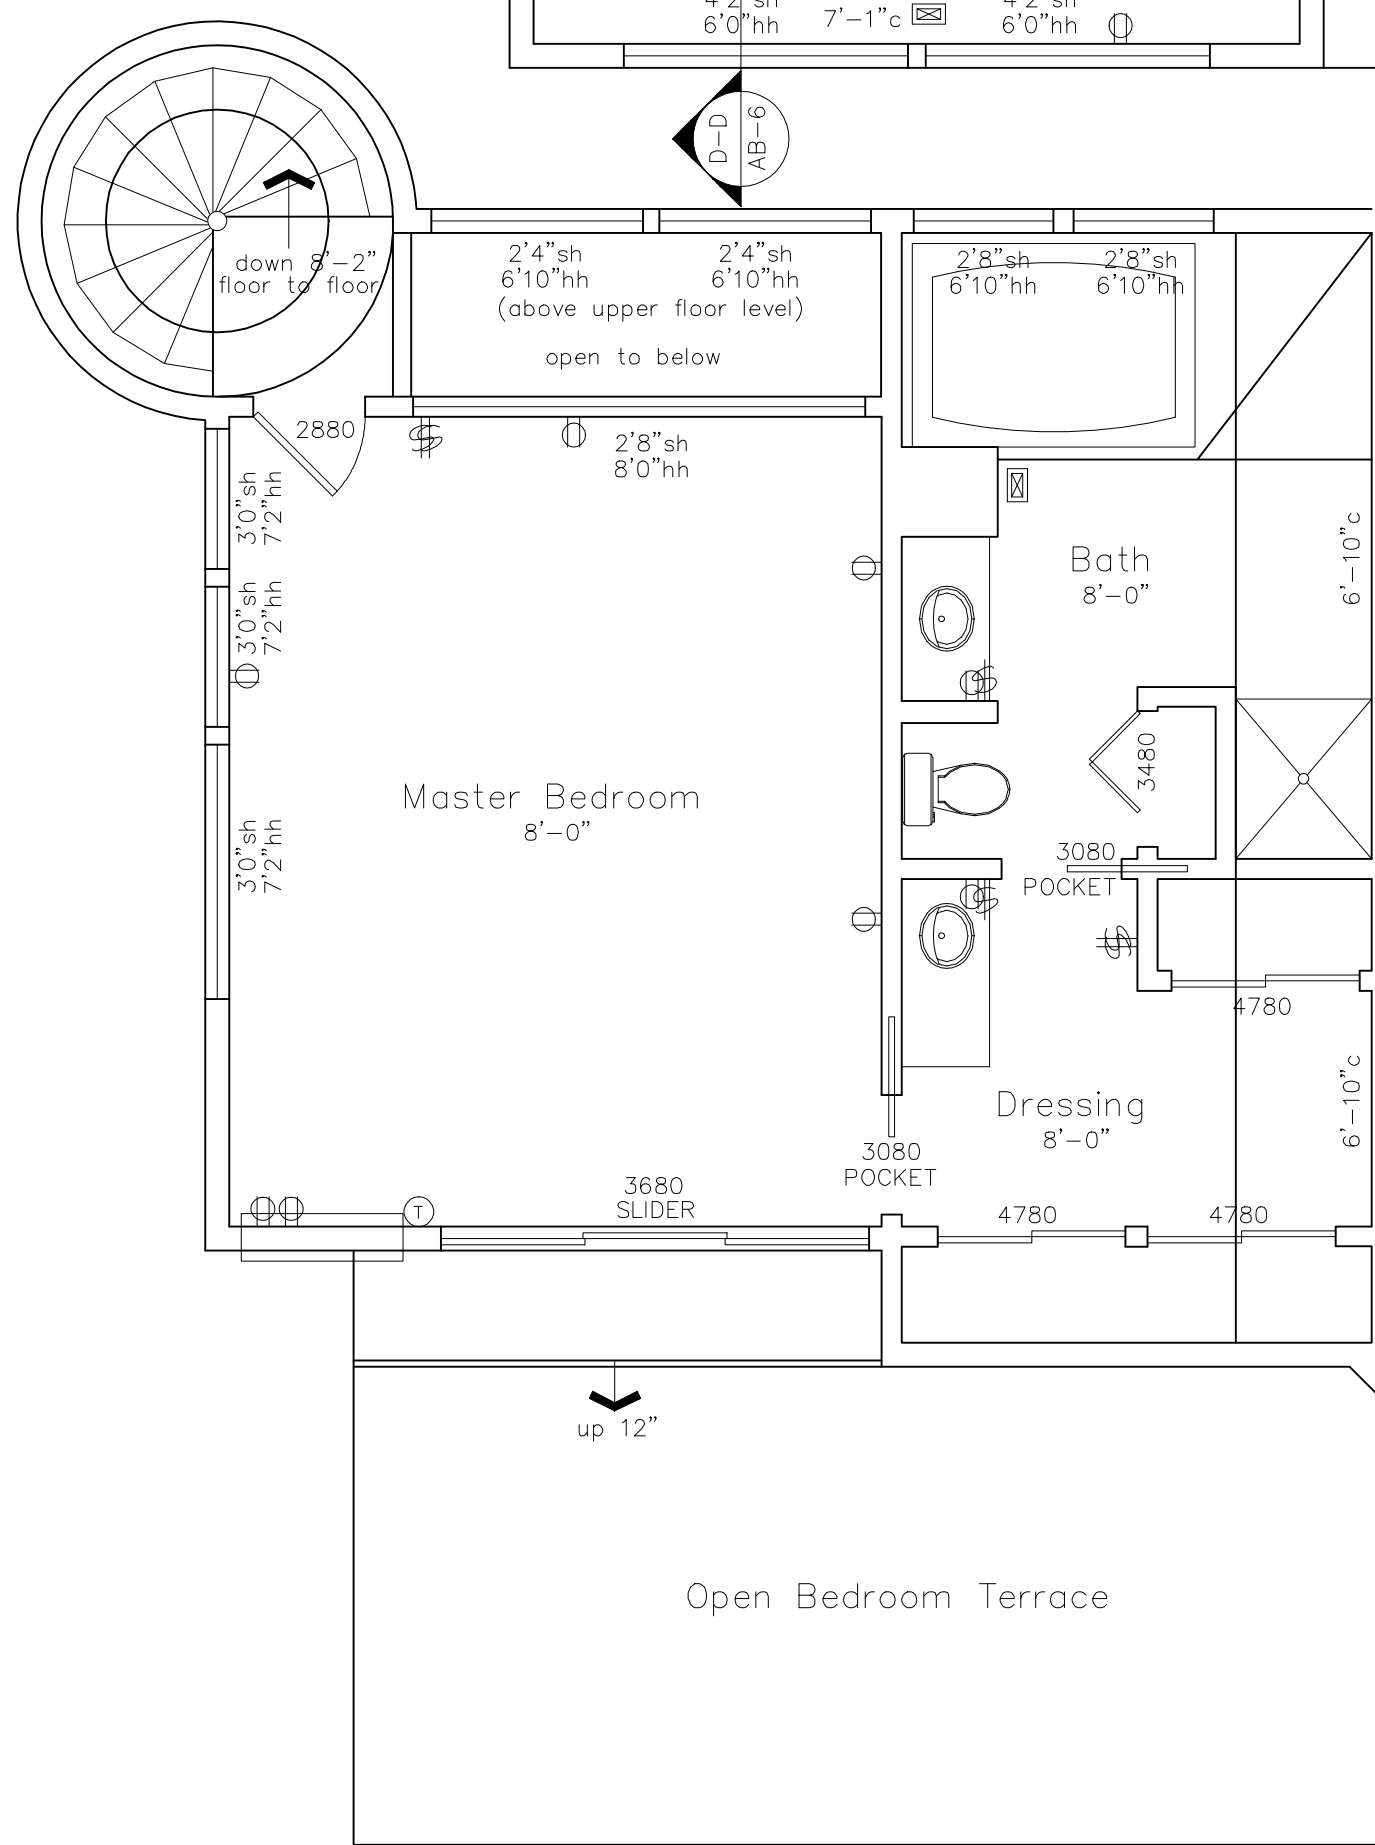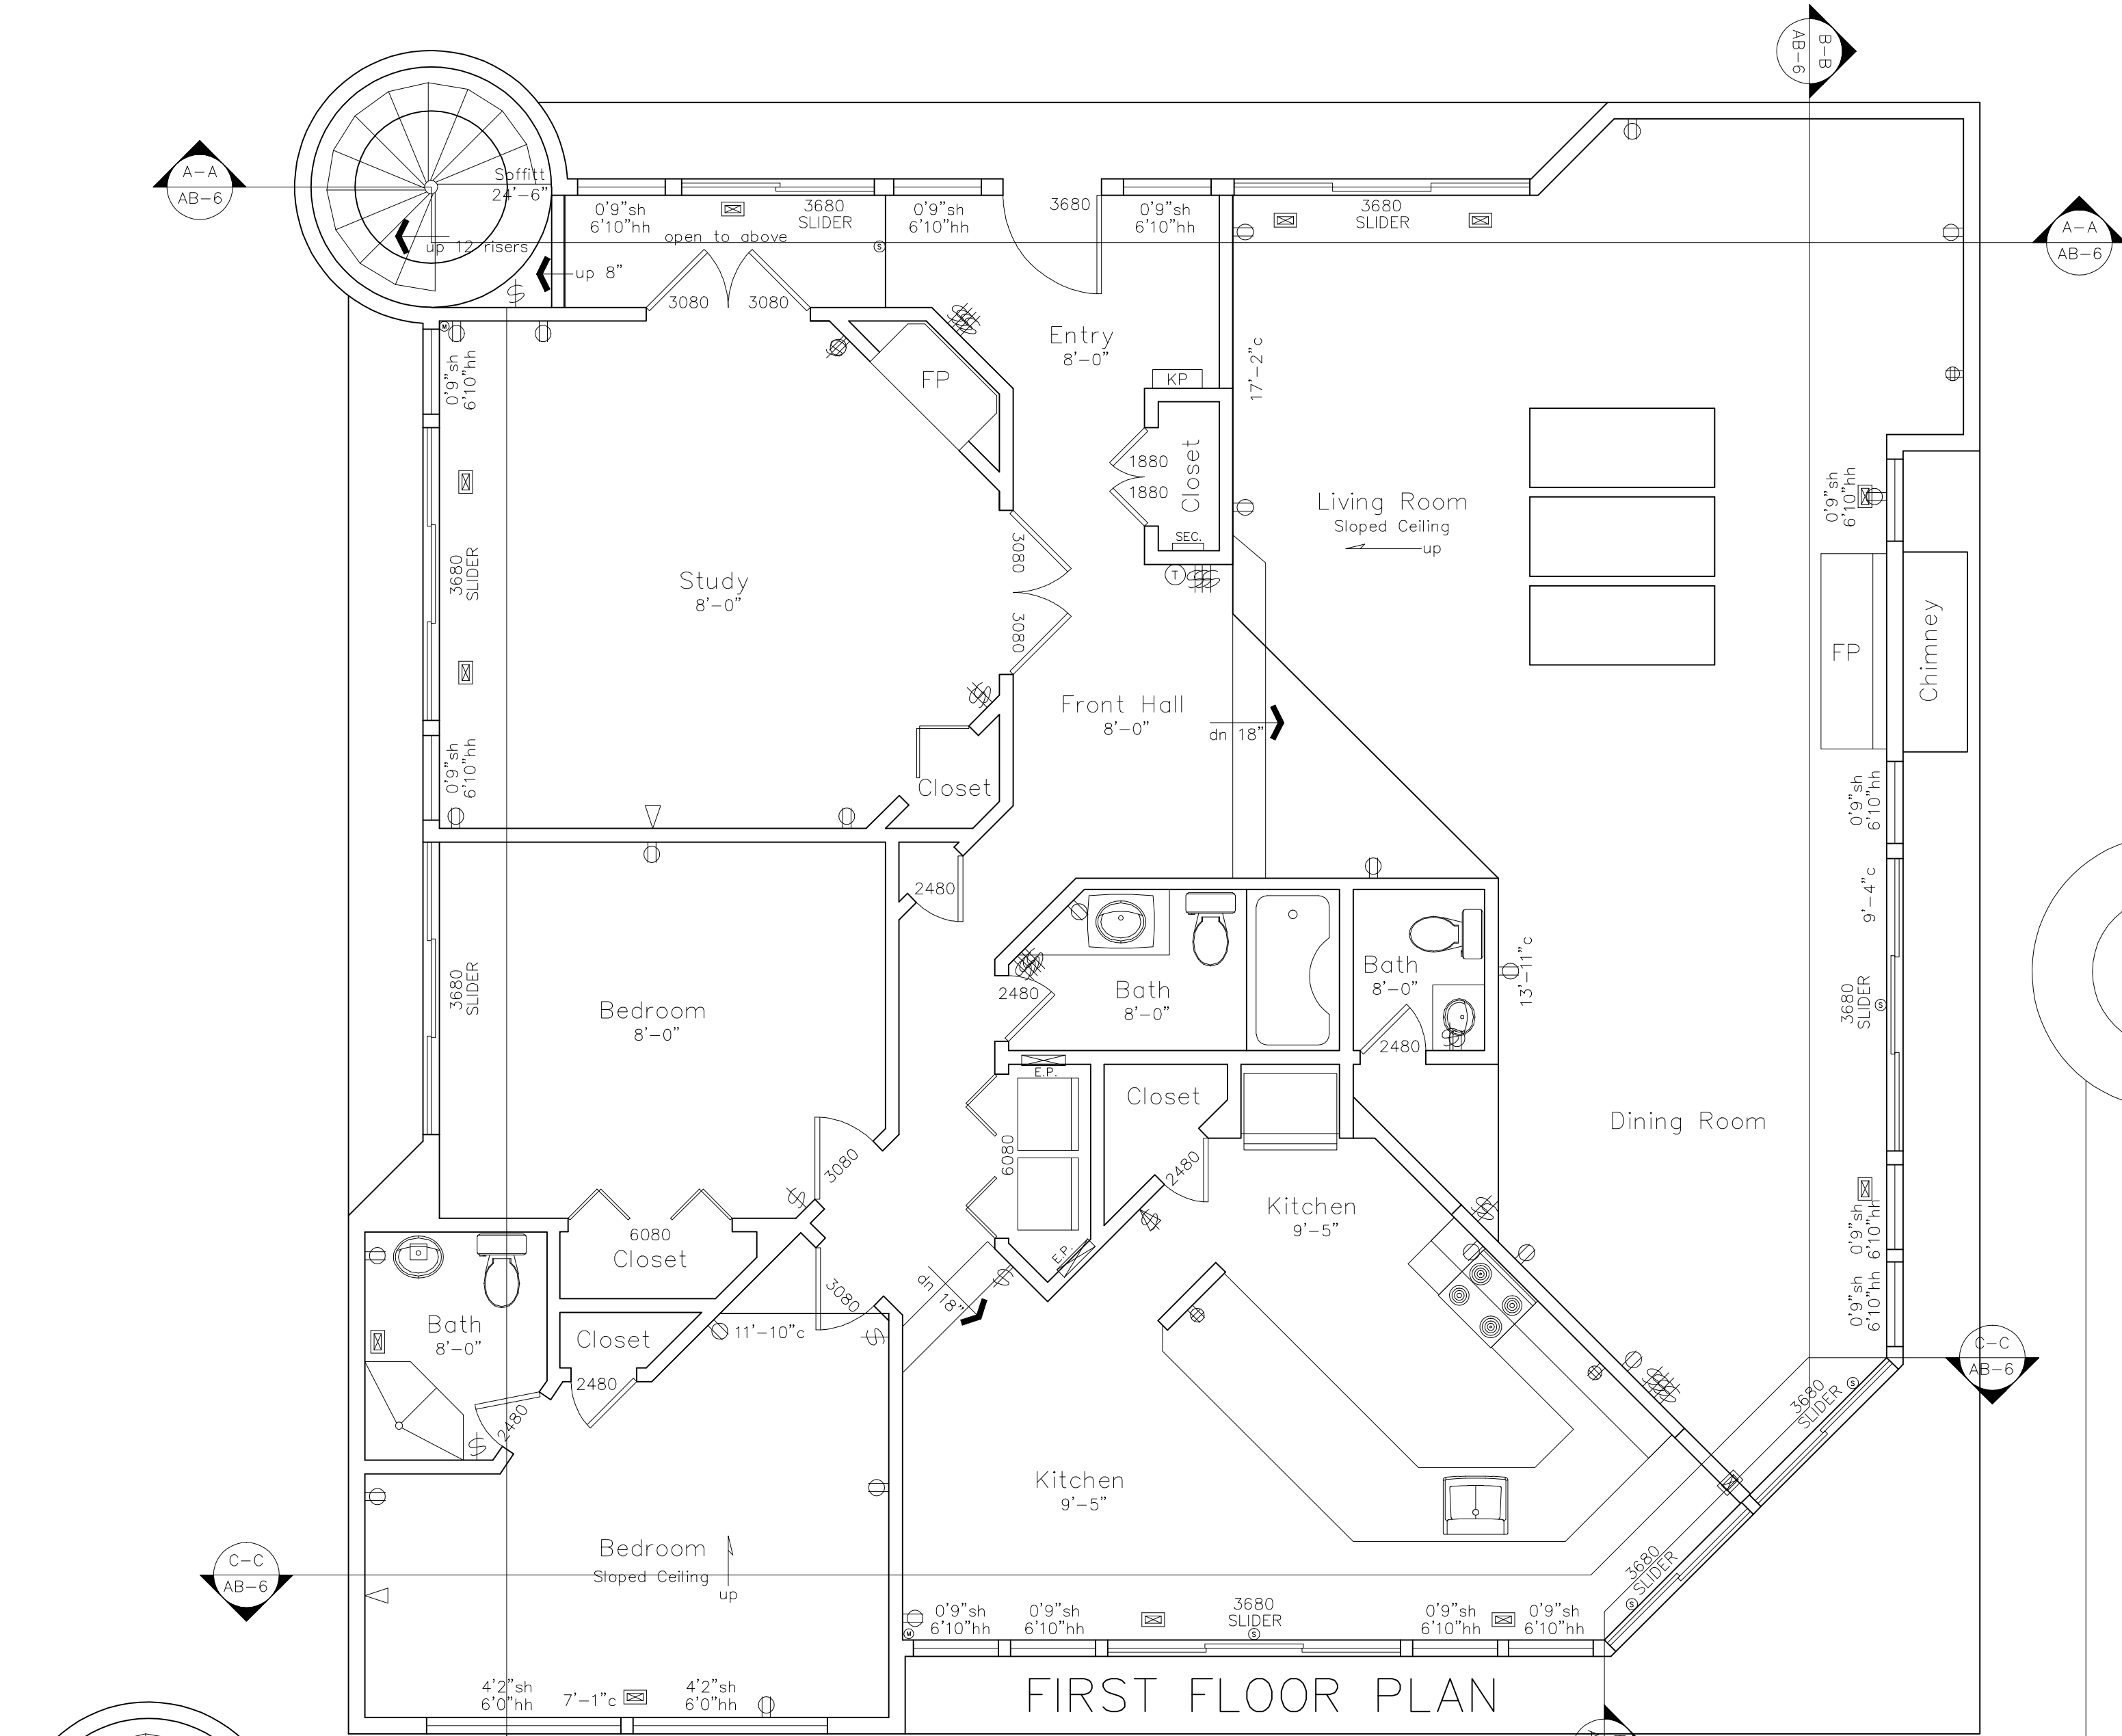AB-1



As BUILT

PROFESSIONALS

www.asbuiltprofessionals.com

A DIVISION OF:

AEC

CONSULTANTS INC

844.272.8458





844 A S BUILT

ARCHITECTURAL AS BUILT

Sag Harbor, NY 11963

01		100% SUBMISSION	
NO.	ISSUES REVISIONS		DATE
		SHEET TITLE	
HL		PROJECT MANAGER	
HL		PROJECT DIRECTOR	
012317-1		PROJECT NUMBER	
1/4"=1'-0"		SCALE	
CL		DRAWN BY	
		SHEET NUMBER	

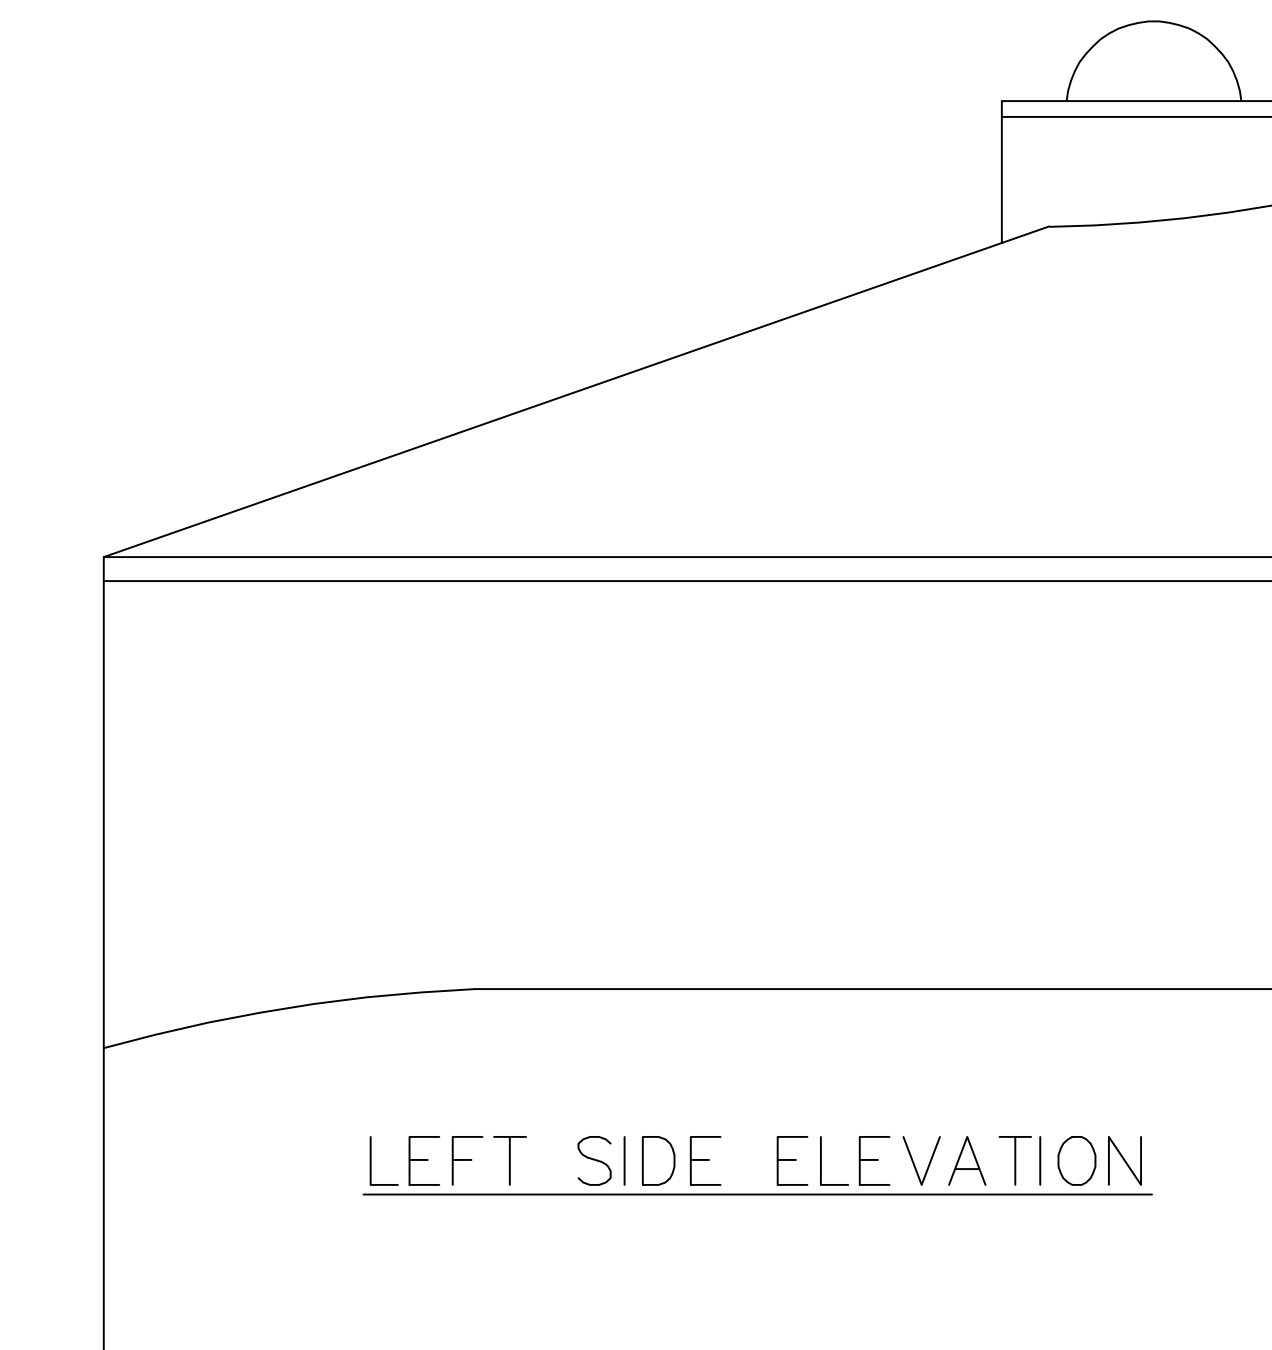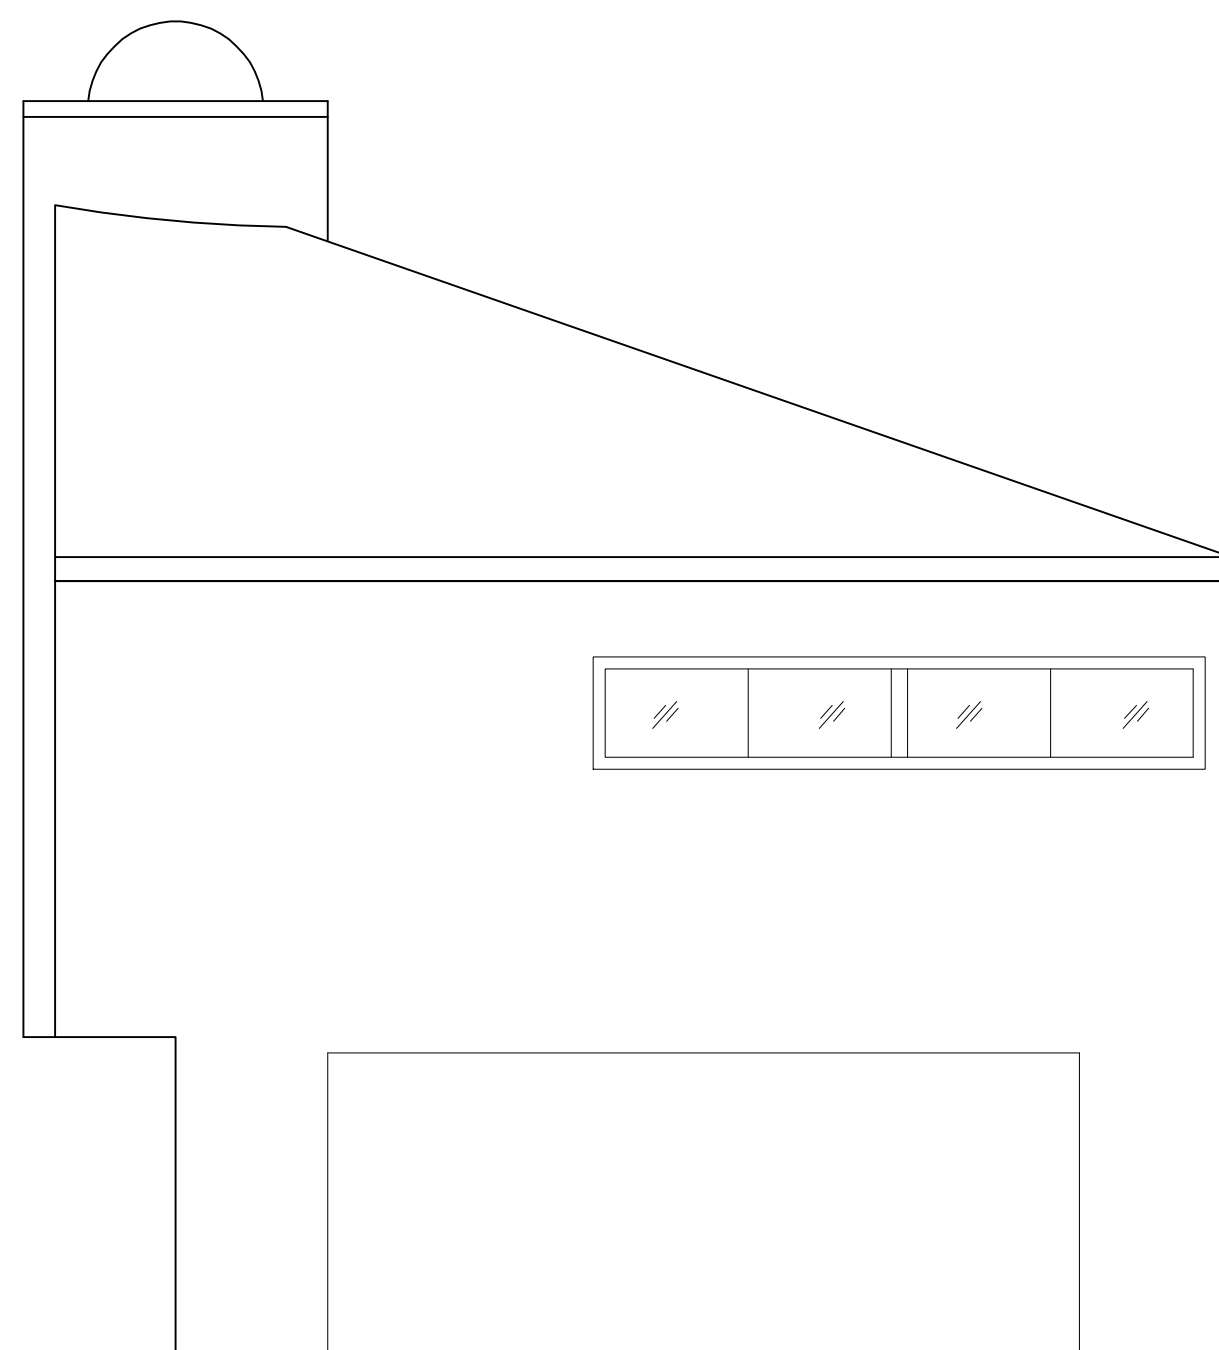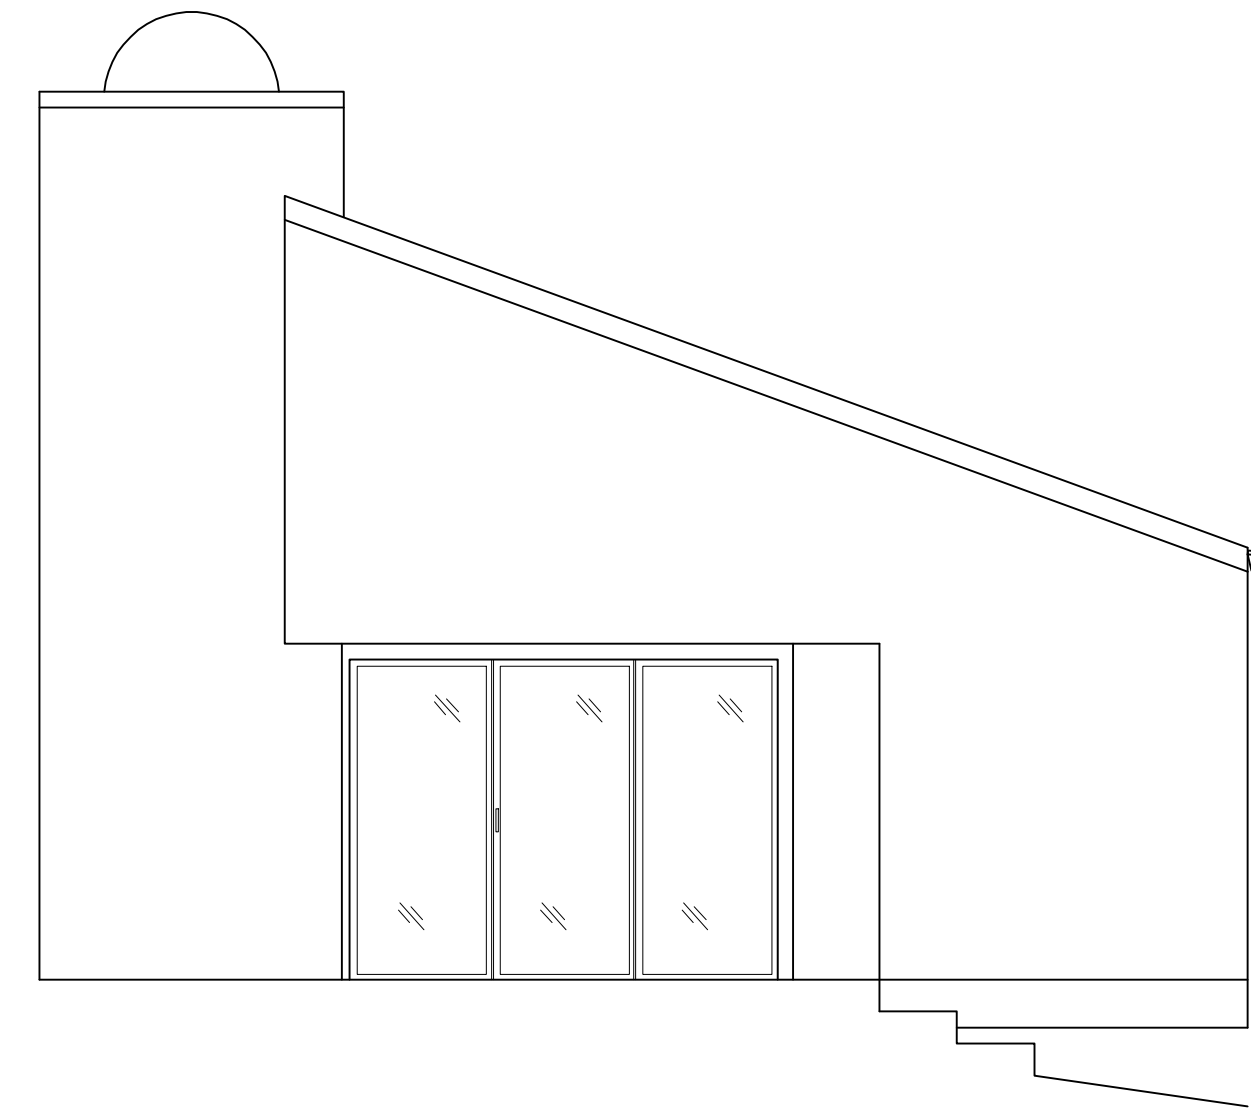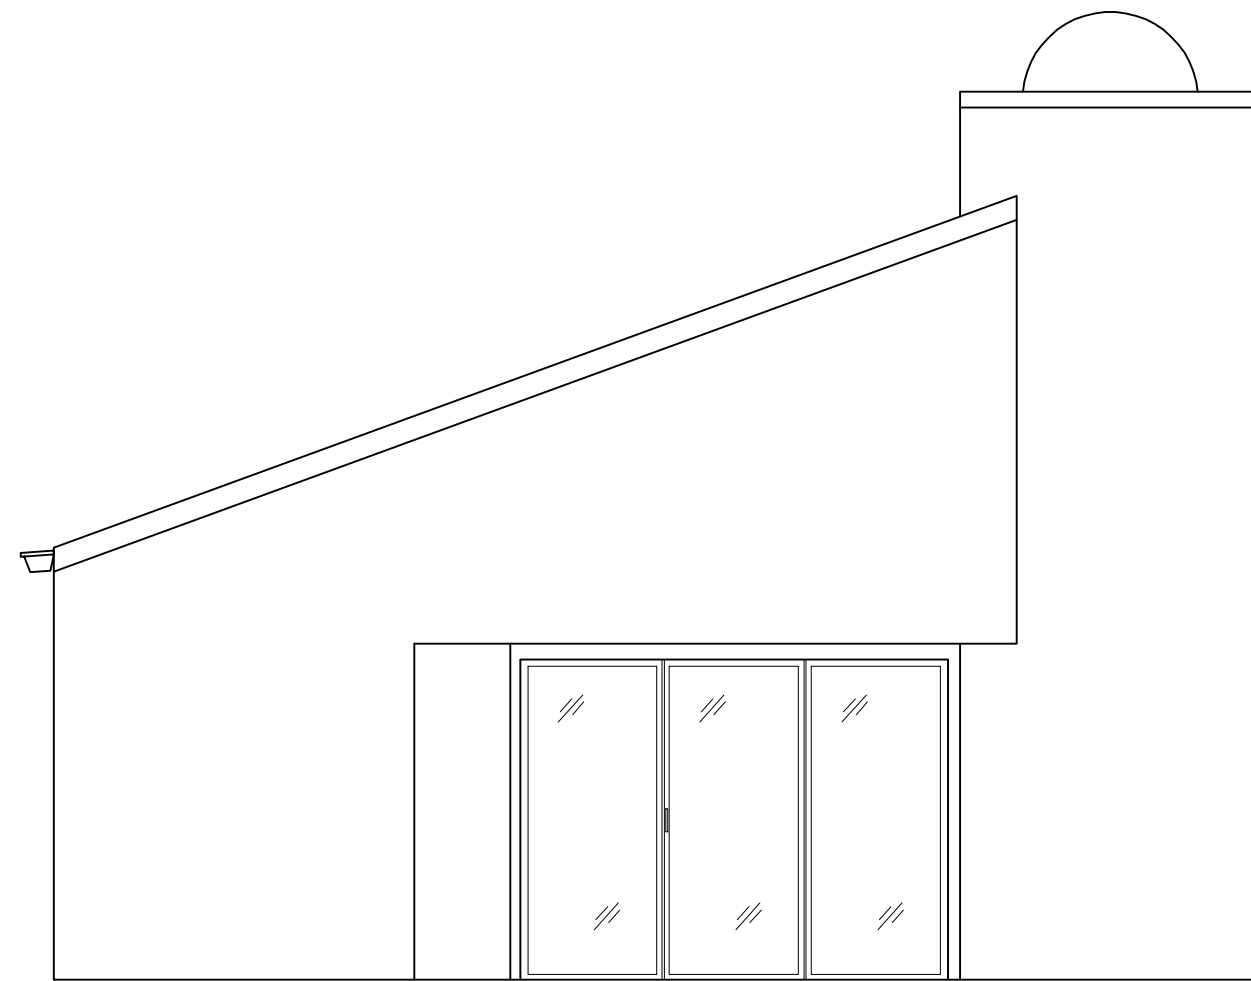
AB-2




ARCHITECTURAL AS BUILT

Sag Harbor, NY 11963


01	100% SUBMISSION	
NO.	ISSUES REVISIONS	DATE
		SHEET TITLE
HL	PROJECT MANAGER	
HL	PROJECT DIRECTOR	
012317-1	PROJECT NUMBER	
1/4"=1'-0"	SCALE	
CL	DRAWN BY	
		SHEET NUMBER
AB-3		

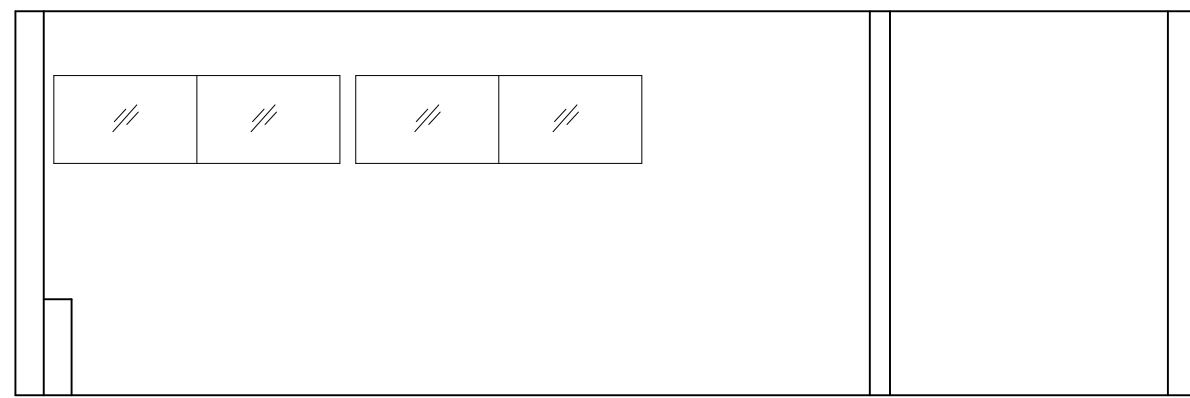


ELEVATION/SECTION "A"

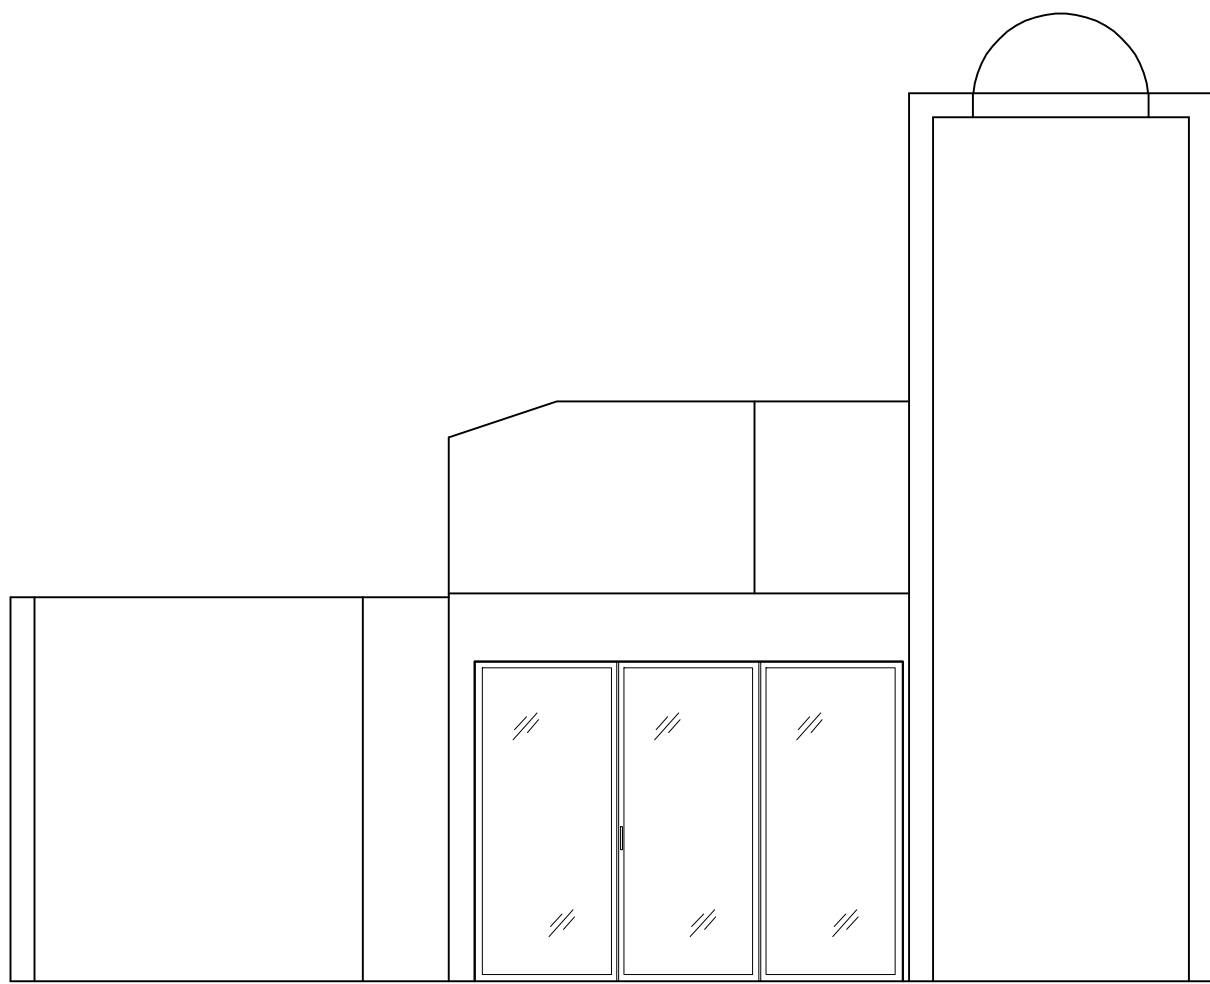

ELEVATION/SECTION "B"

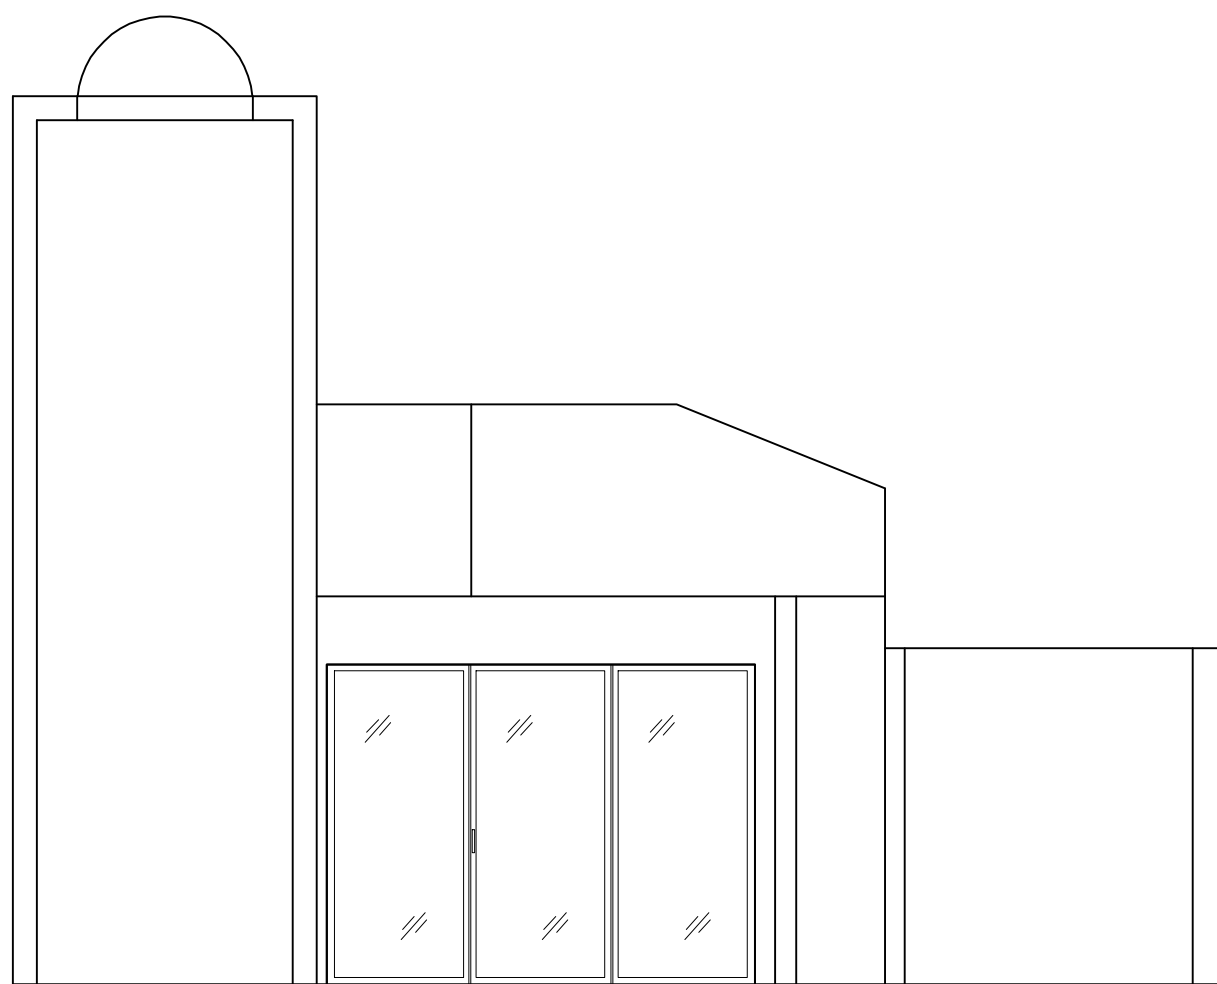

ELEVATION/SECTION "C"

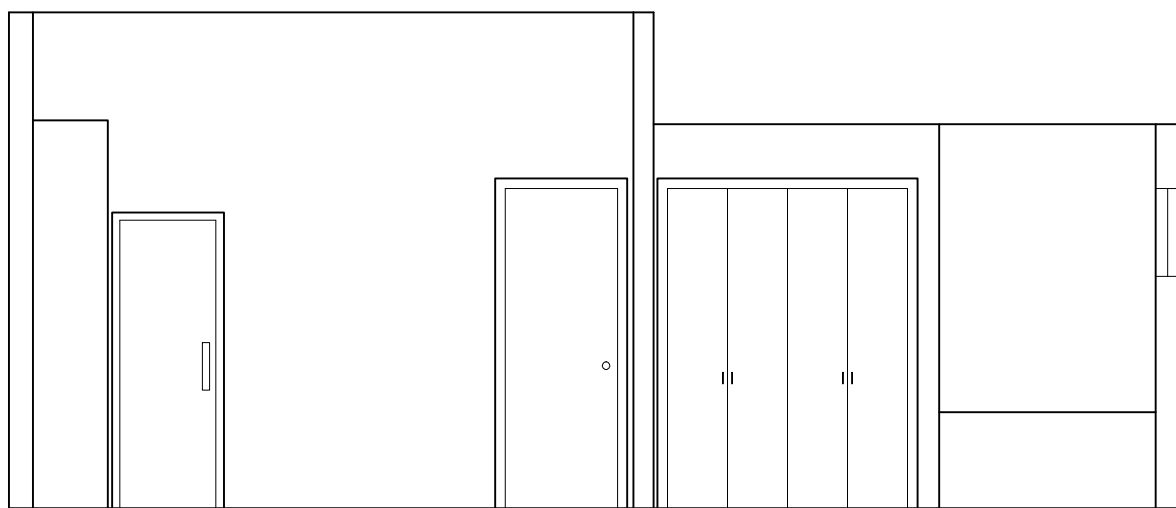

ELEVATION/SECTION "D"

As BUILT

PROFESSIONALS

www.asbuiltprofessionals.com

A DIVISION OF:

AEC

CONSULTANTS INC

844.272.8458





844 A S B U I L T

© 2017 AEC CONSULTANTS INC

ARCHITECTURAL AS BUILT

Sag Harbor, NY 11963

01	100% SUBMISSION	
NO.	ISSUES REVISIONS	DATE
		SHEET TITLE
HL		PROJECT MANAGER
HL		PROJECT DIRECTOR
012317-1		PROJECT NUMBER
1/4"=1'-0"		SCALE
CL		DRAWN BY
		SHEET NUMBER

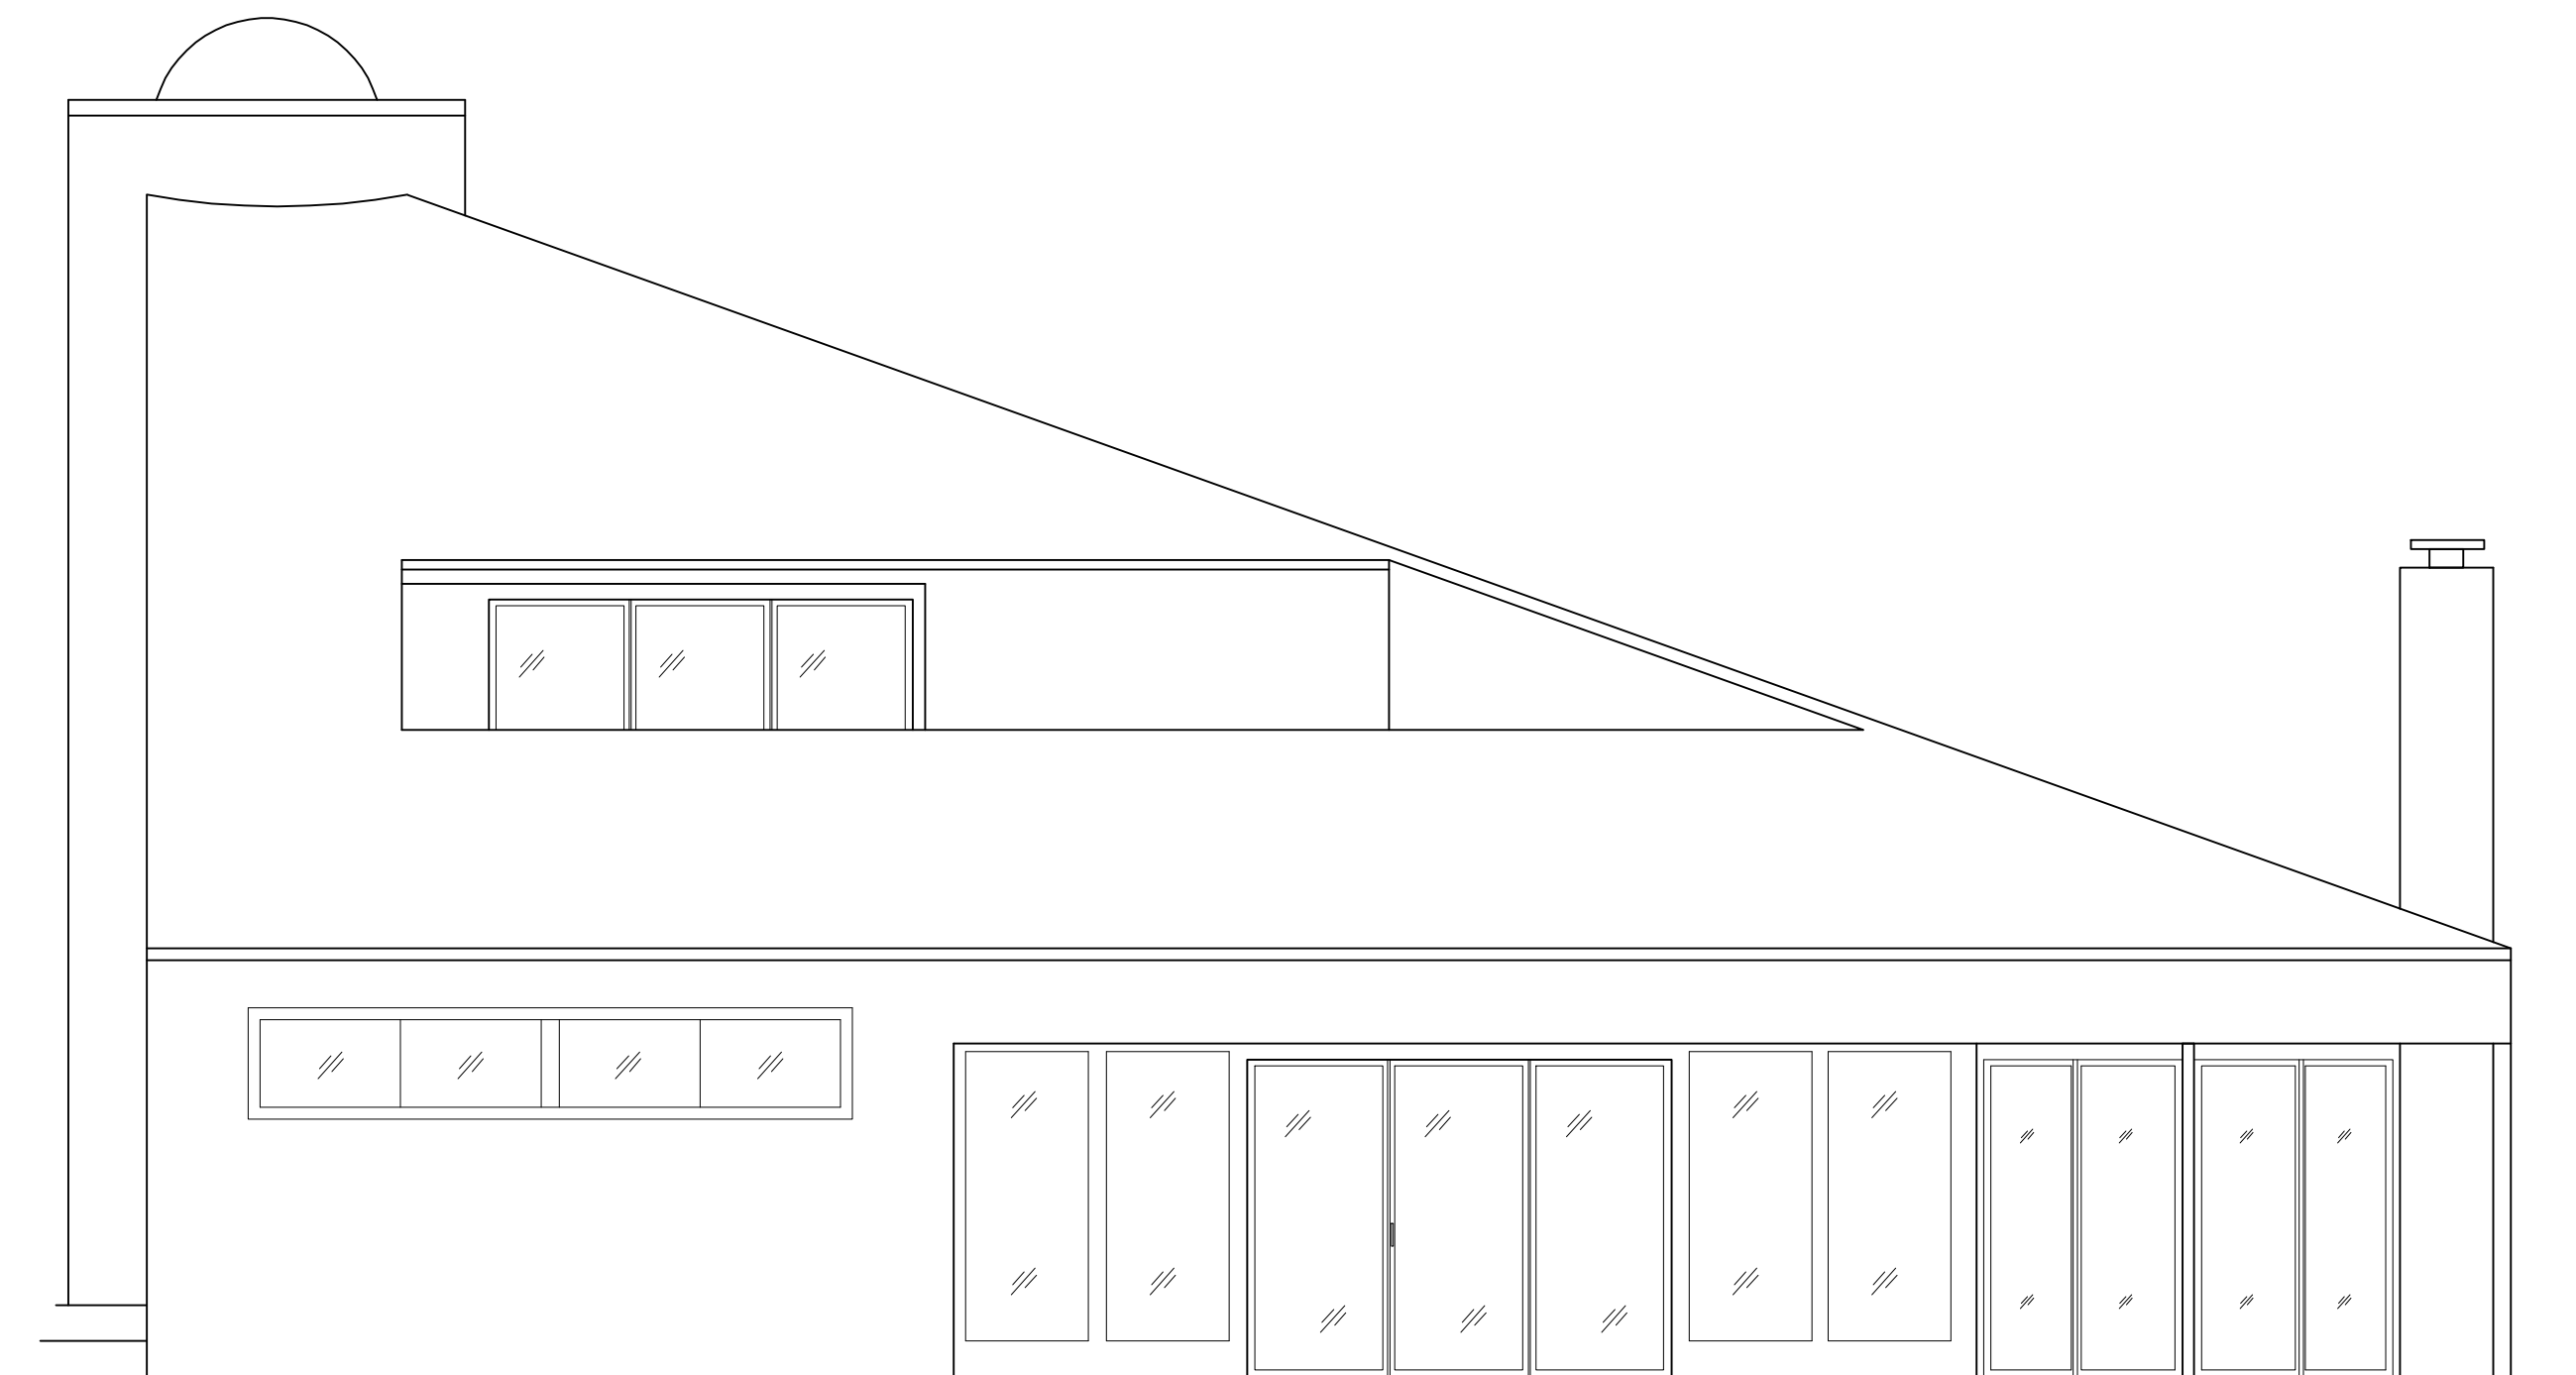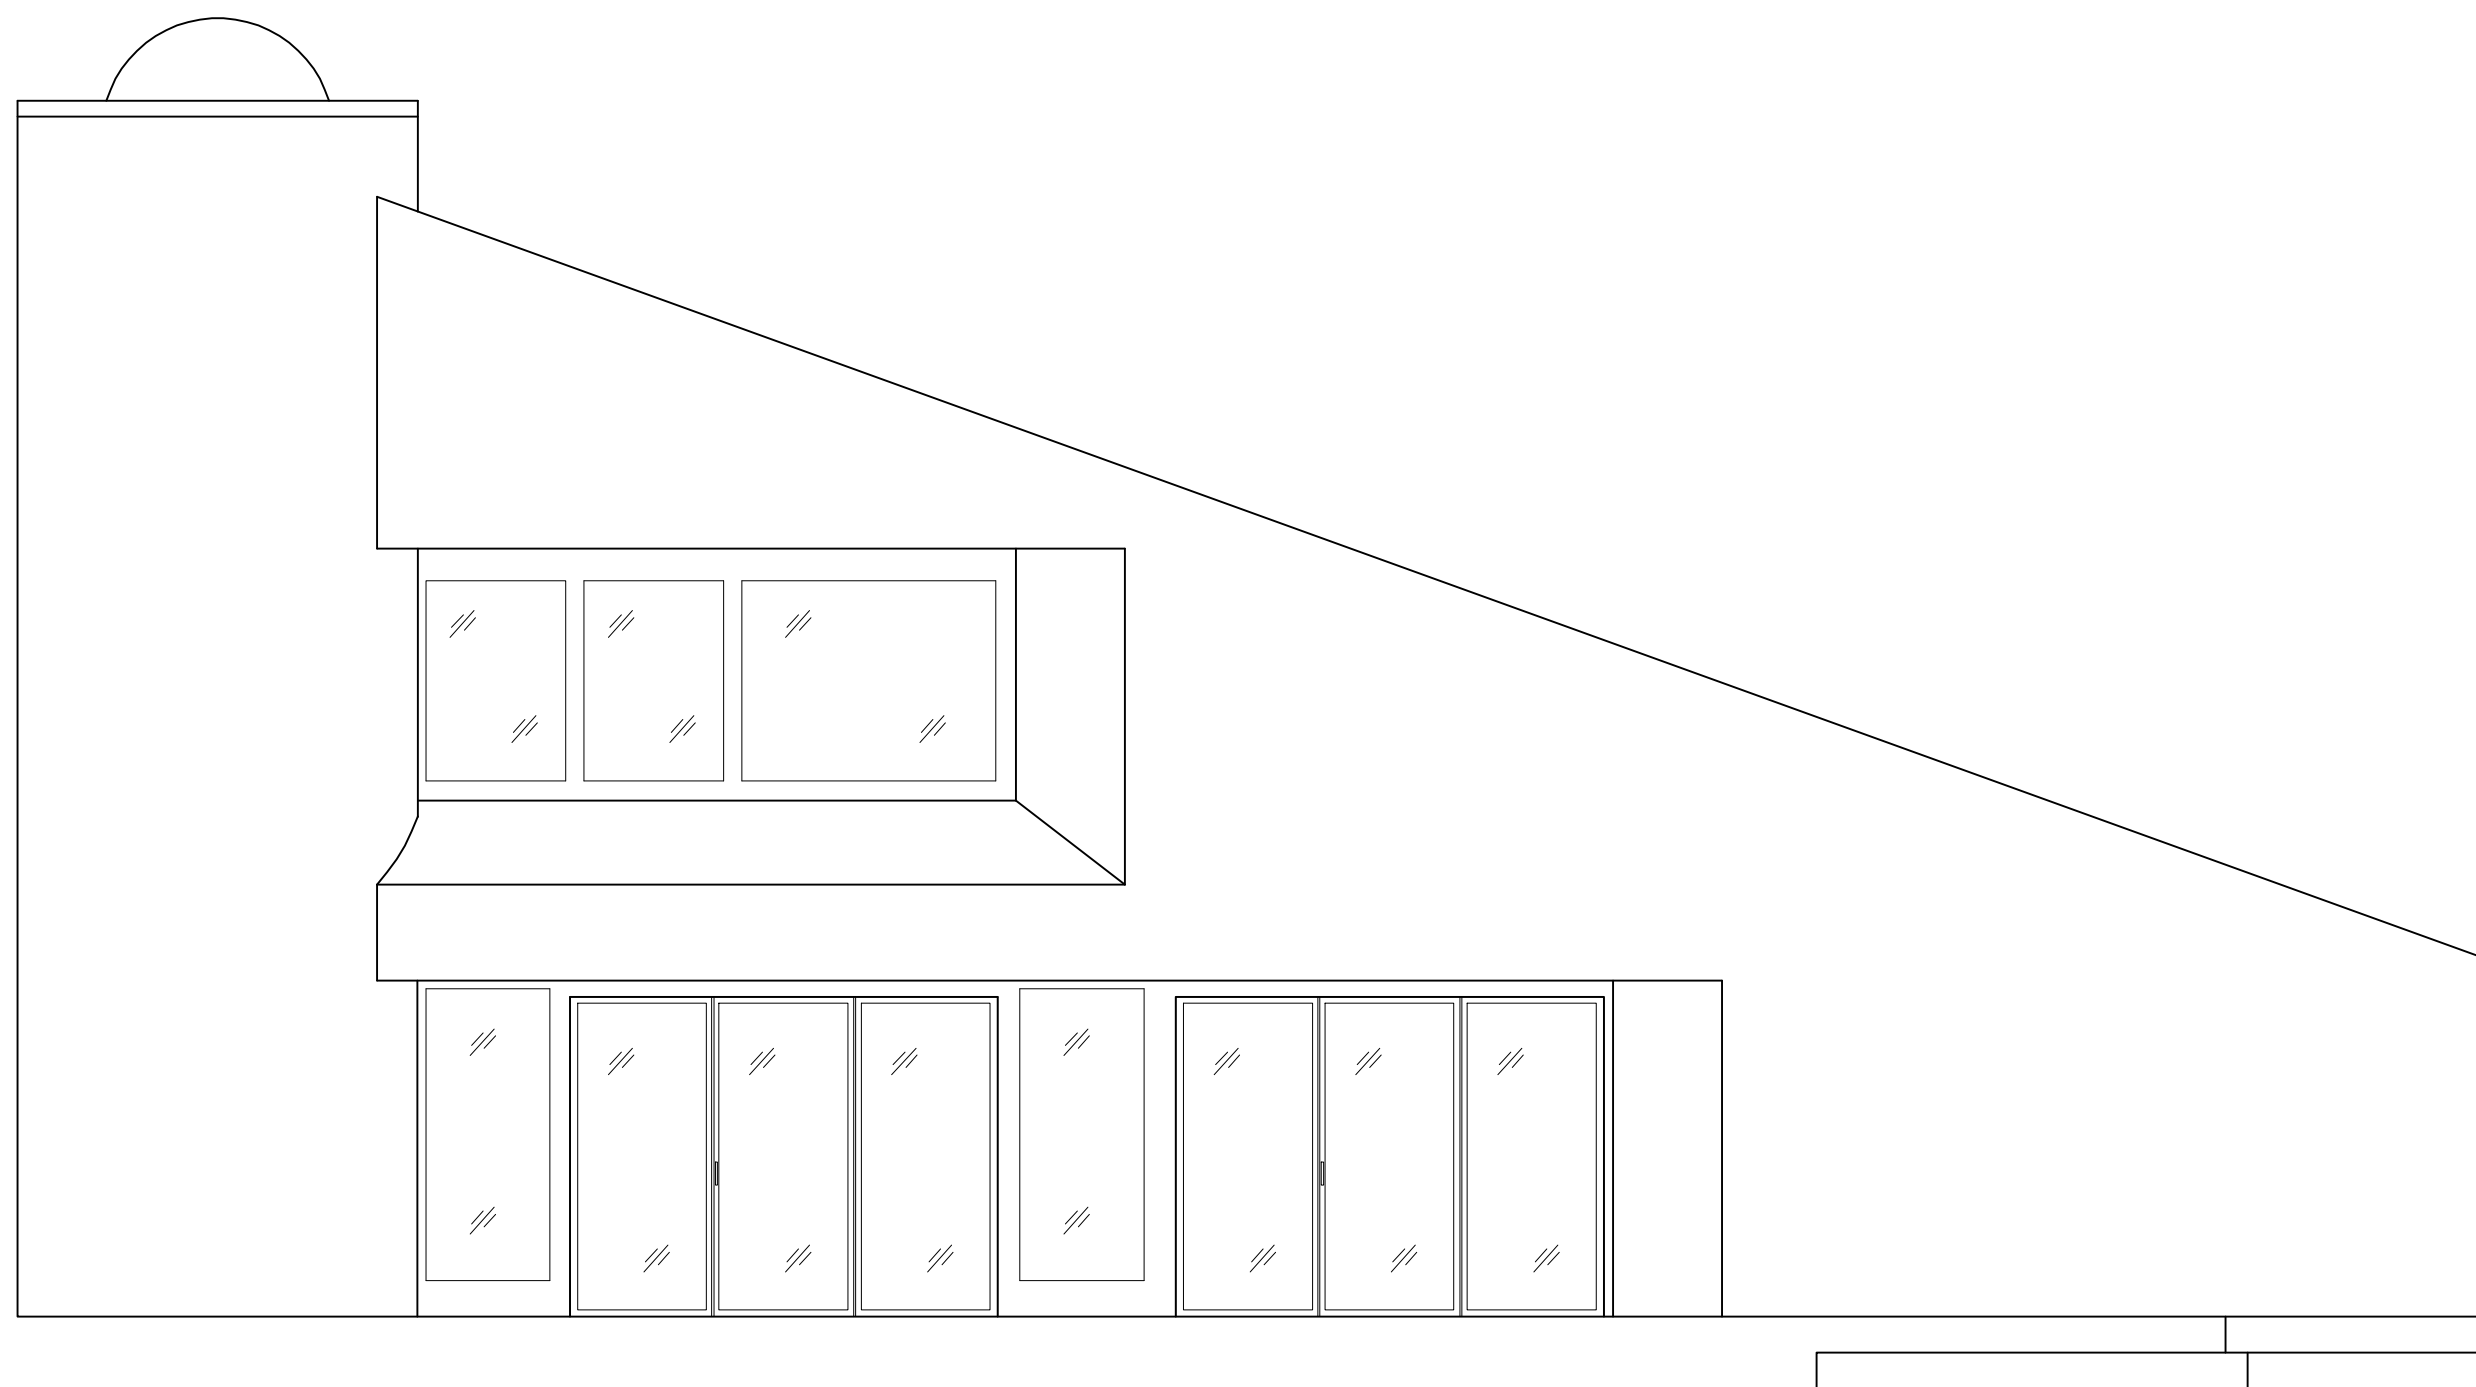
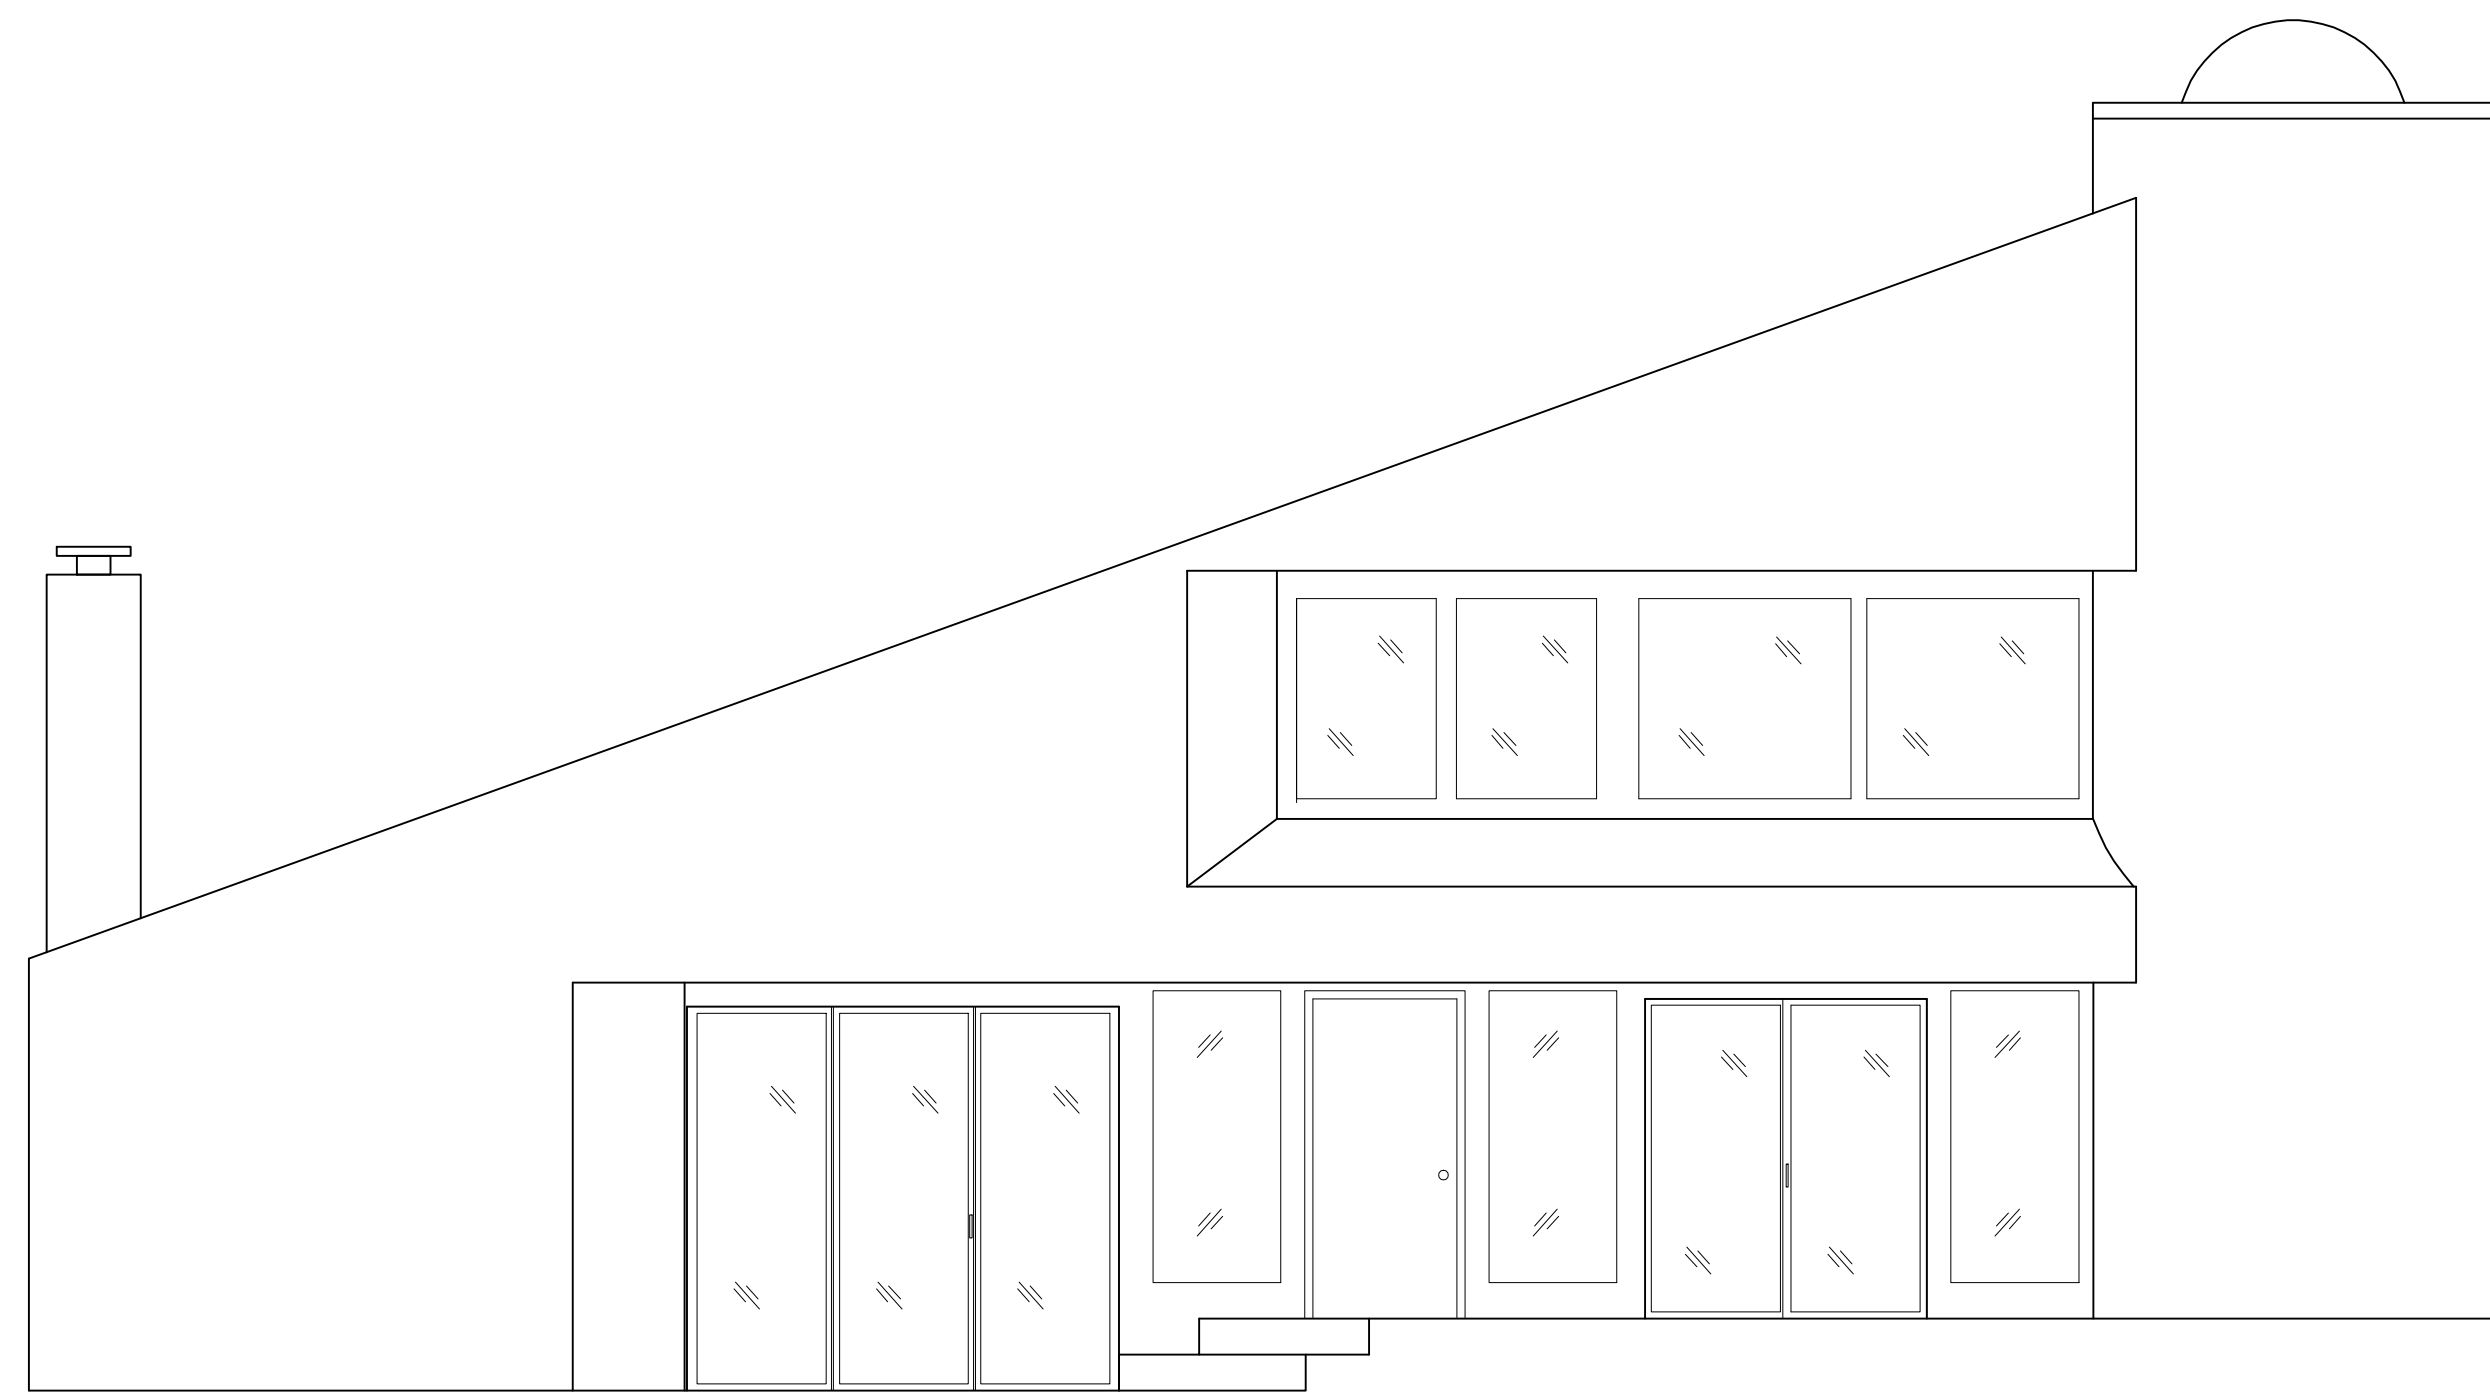
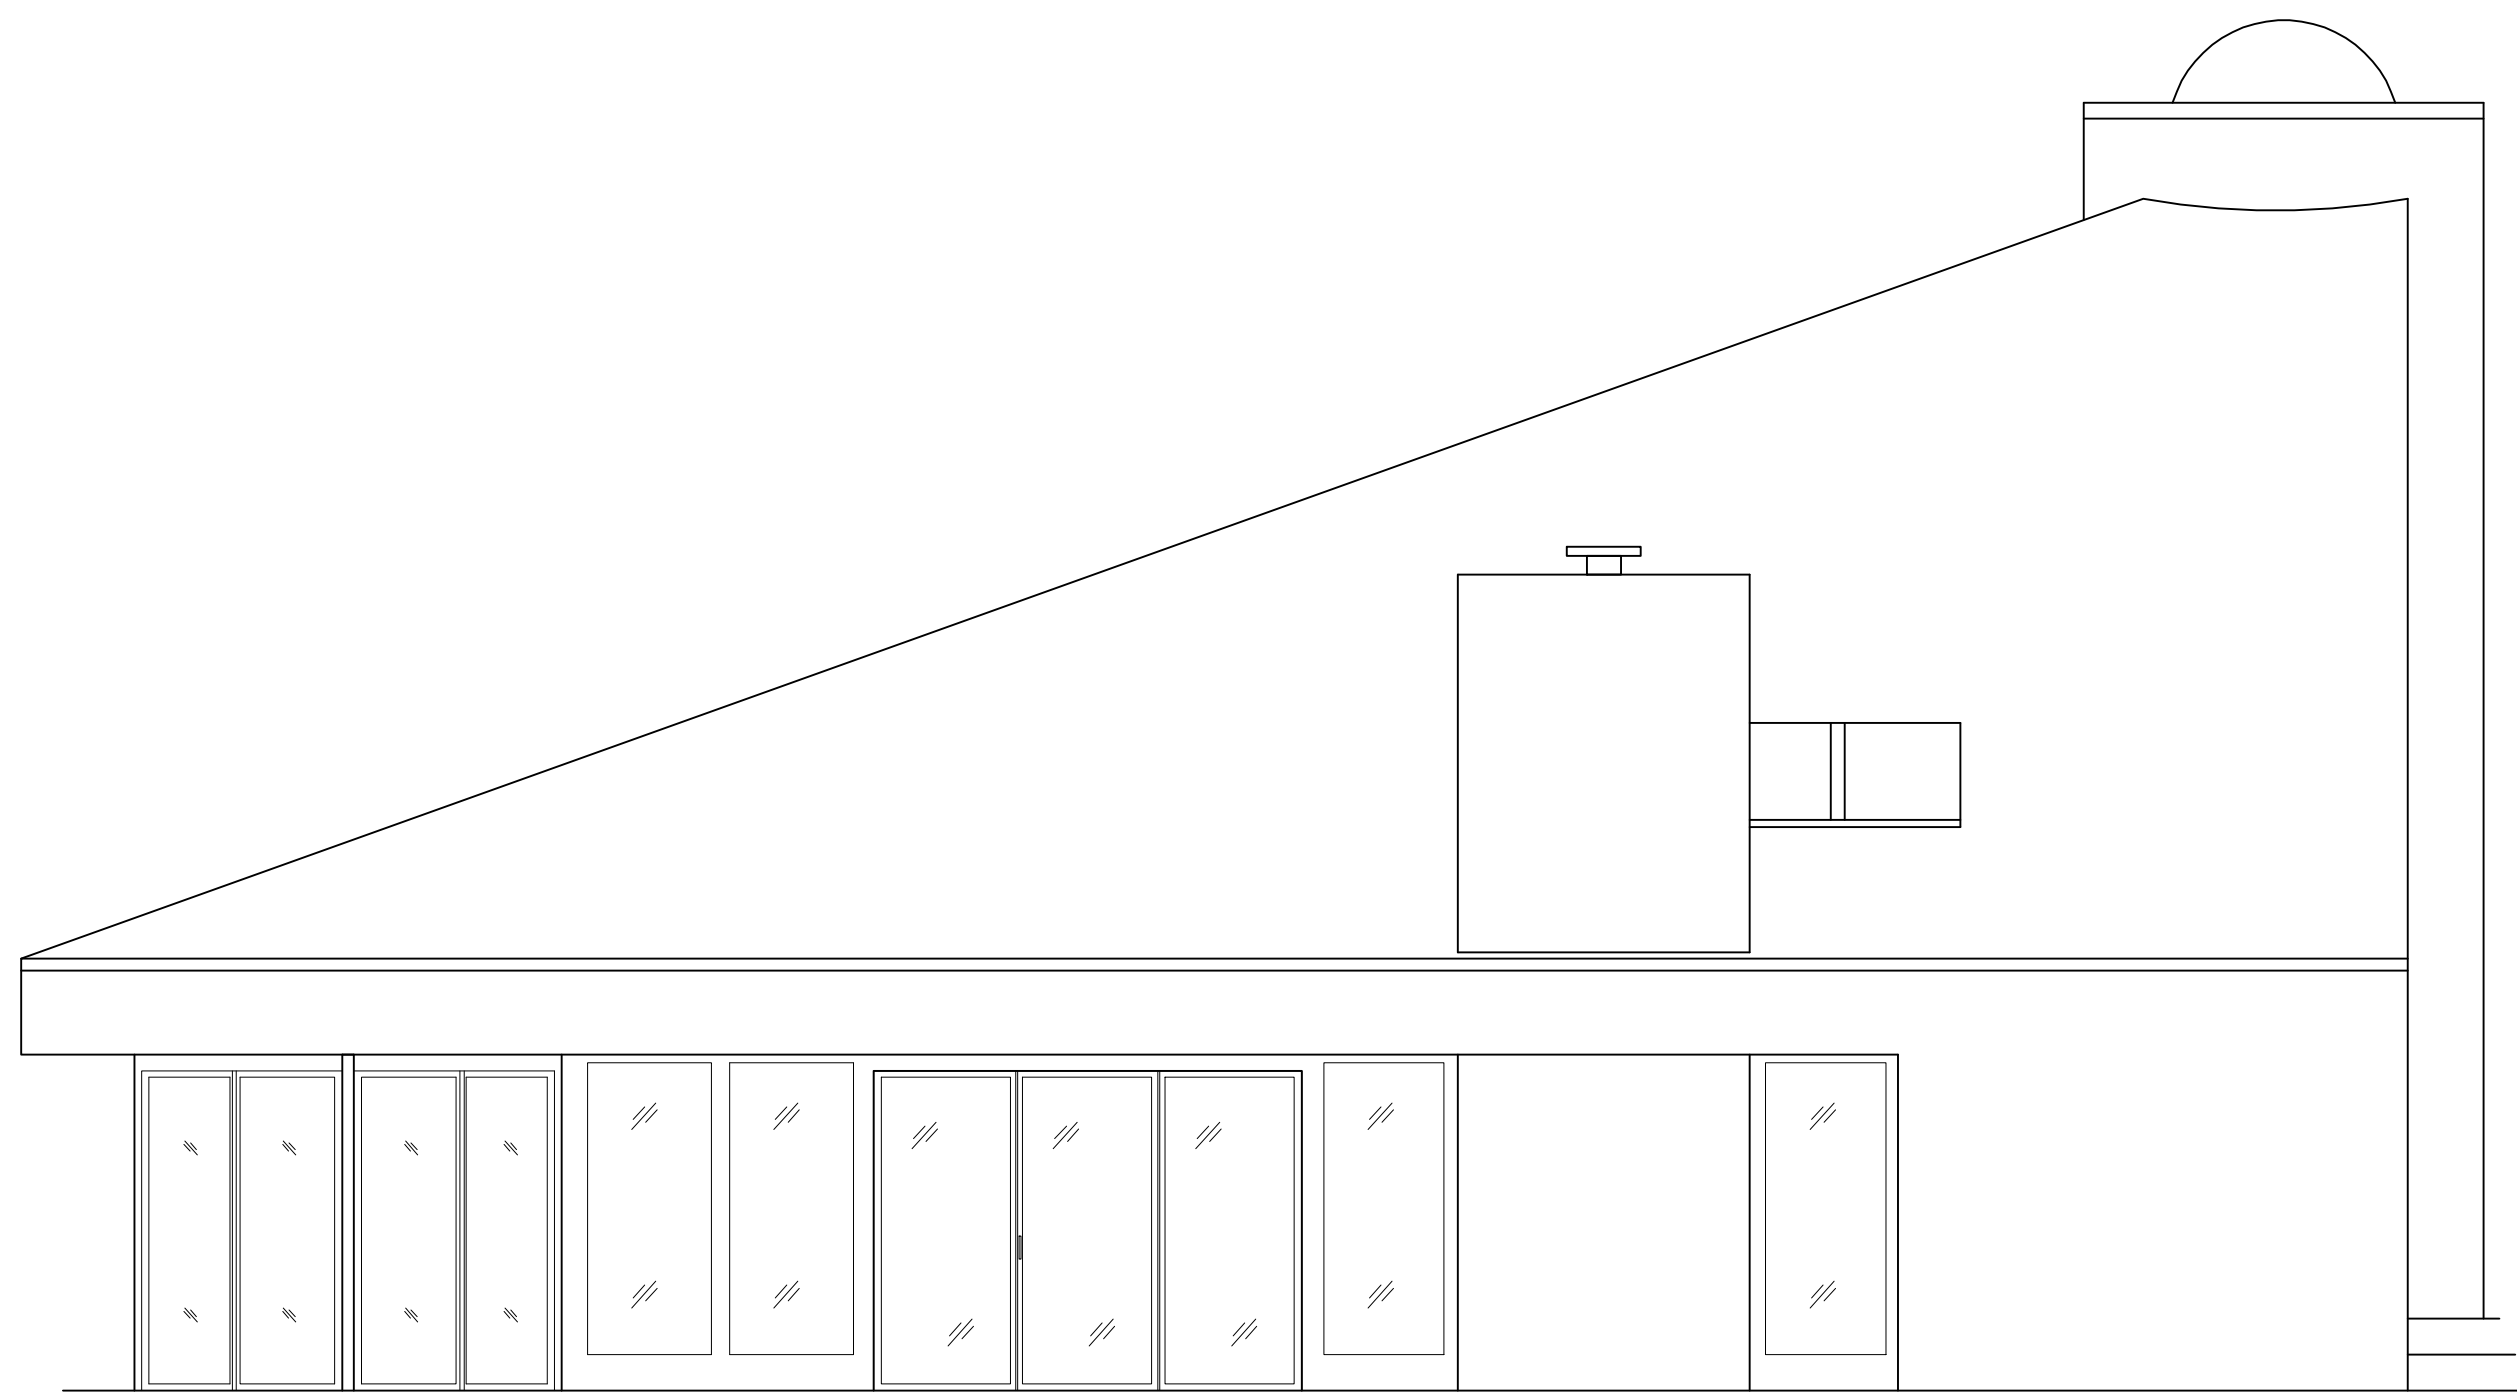


ARCHITECTURAL AS BUILT

Sag Harbor, NY 11963

01	100% SUBMISSION	
NO.	ISSUES REVISIONS	DATE
		SHEET TITLE
HL	PROJECT MANAGER	
HL	PROJECT DIRECTOR	
012317-1		PROJECT NUMBER
1/4"=1'-0"		SCALE
CL	DRAWN BY	
		SHEET NUMBER

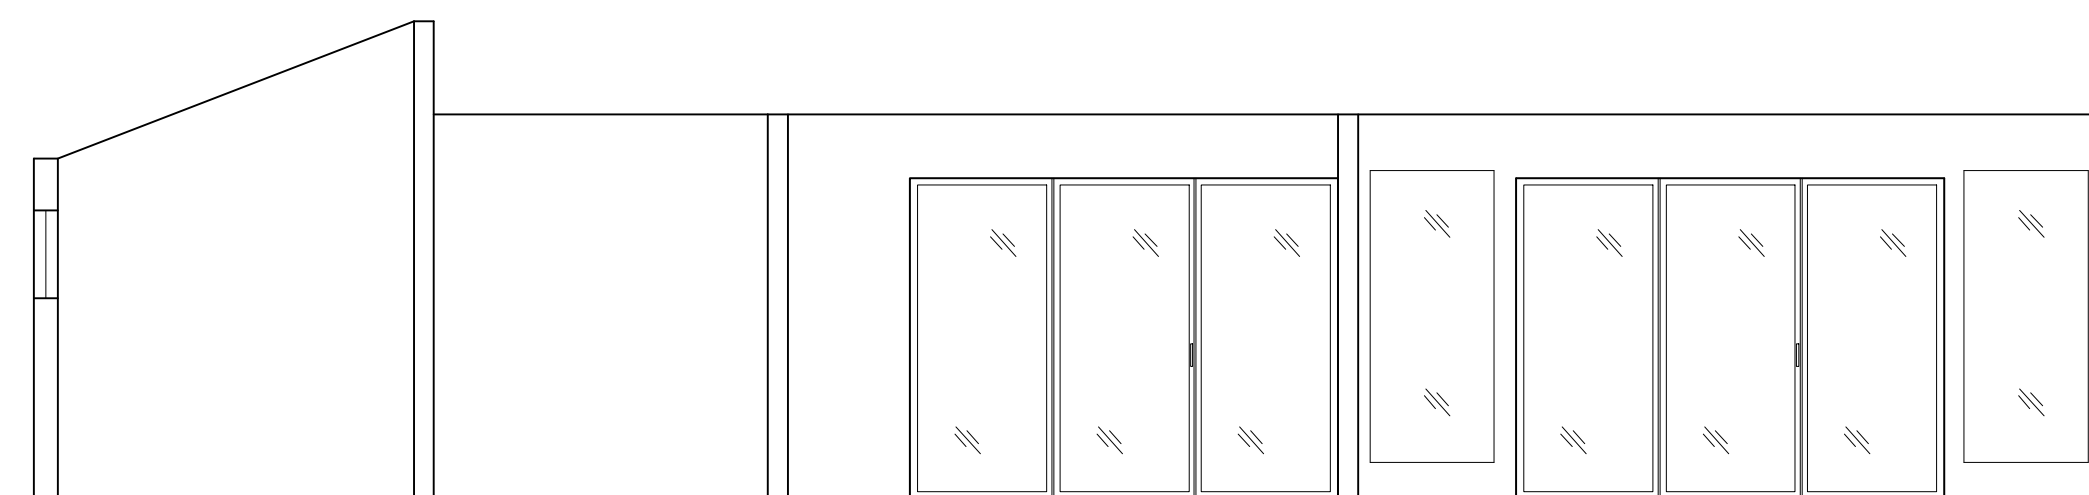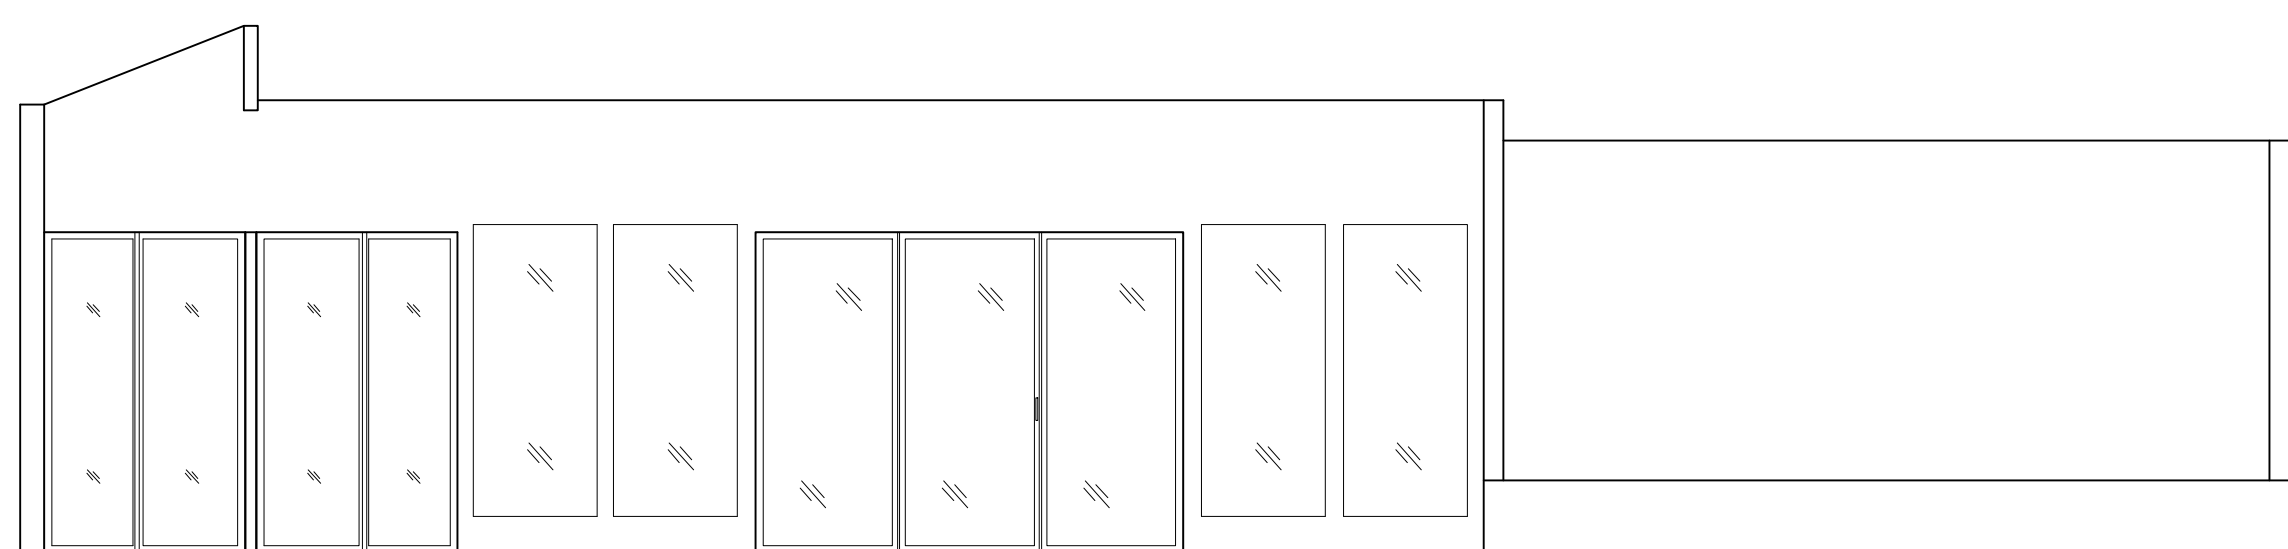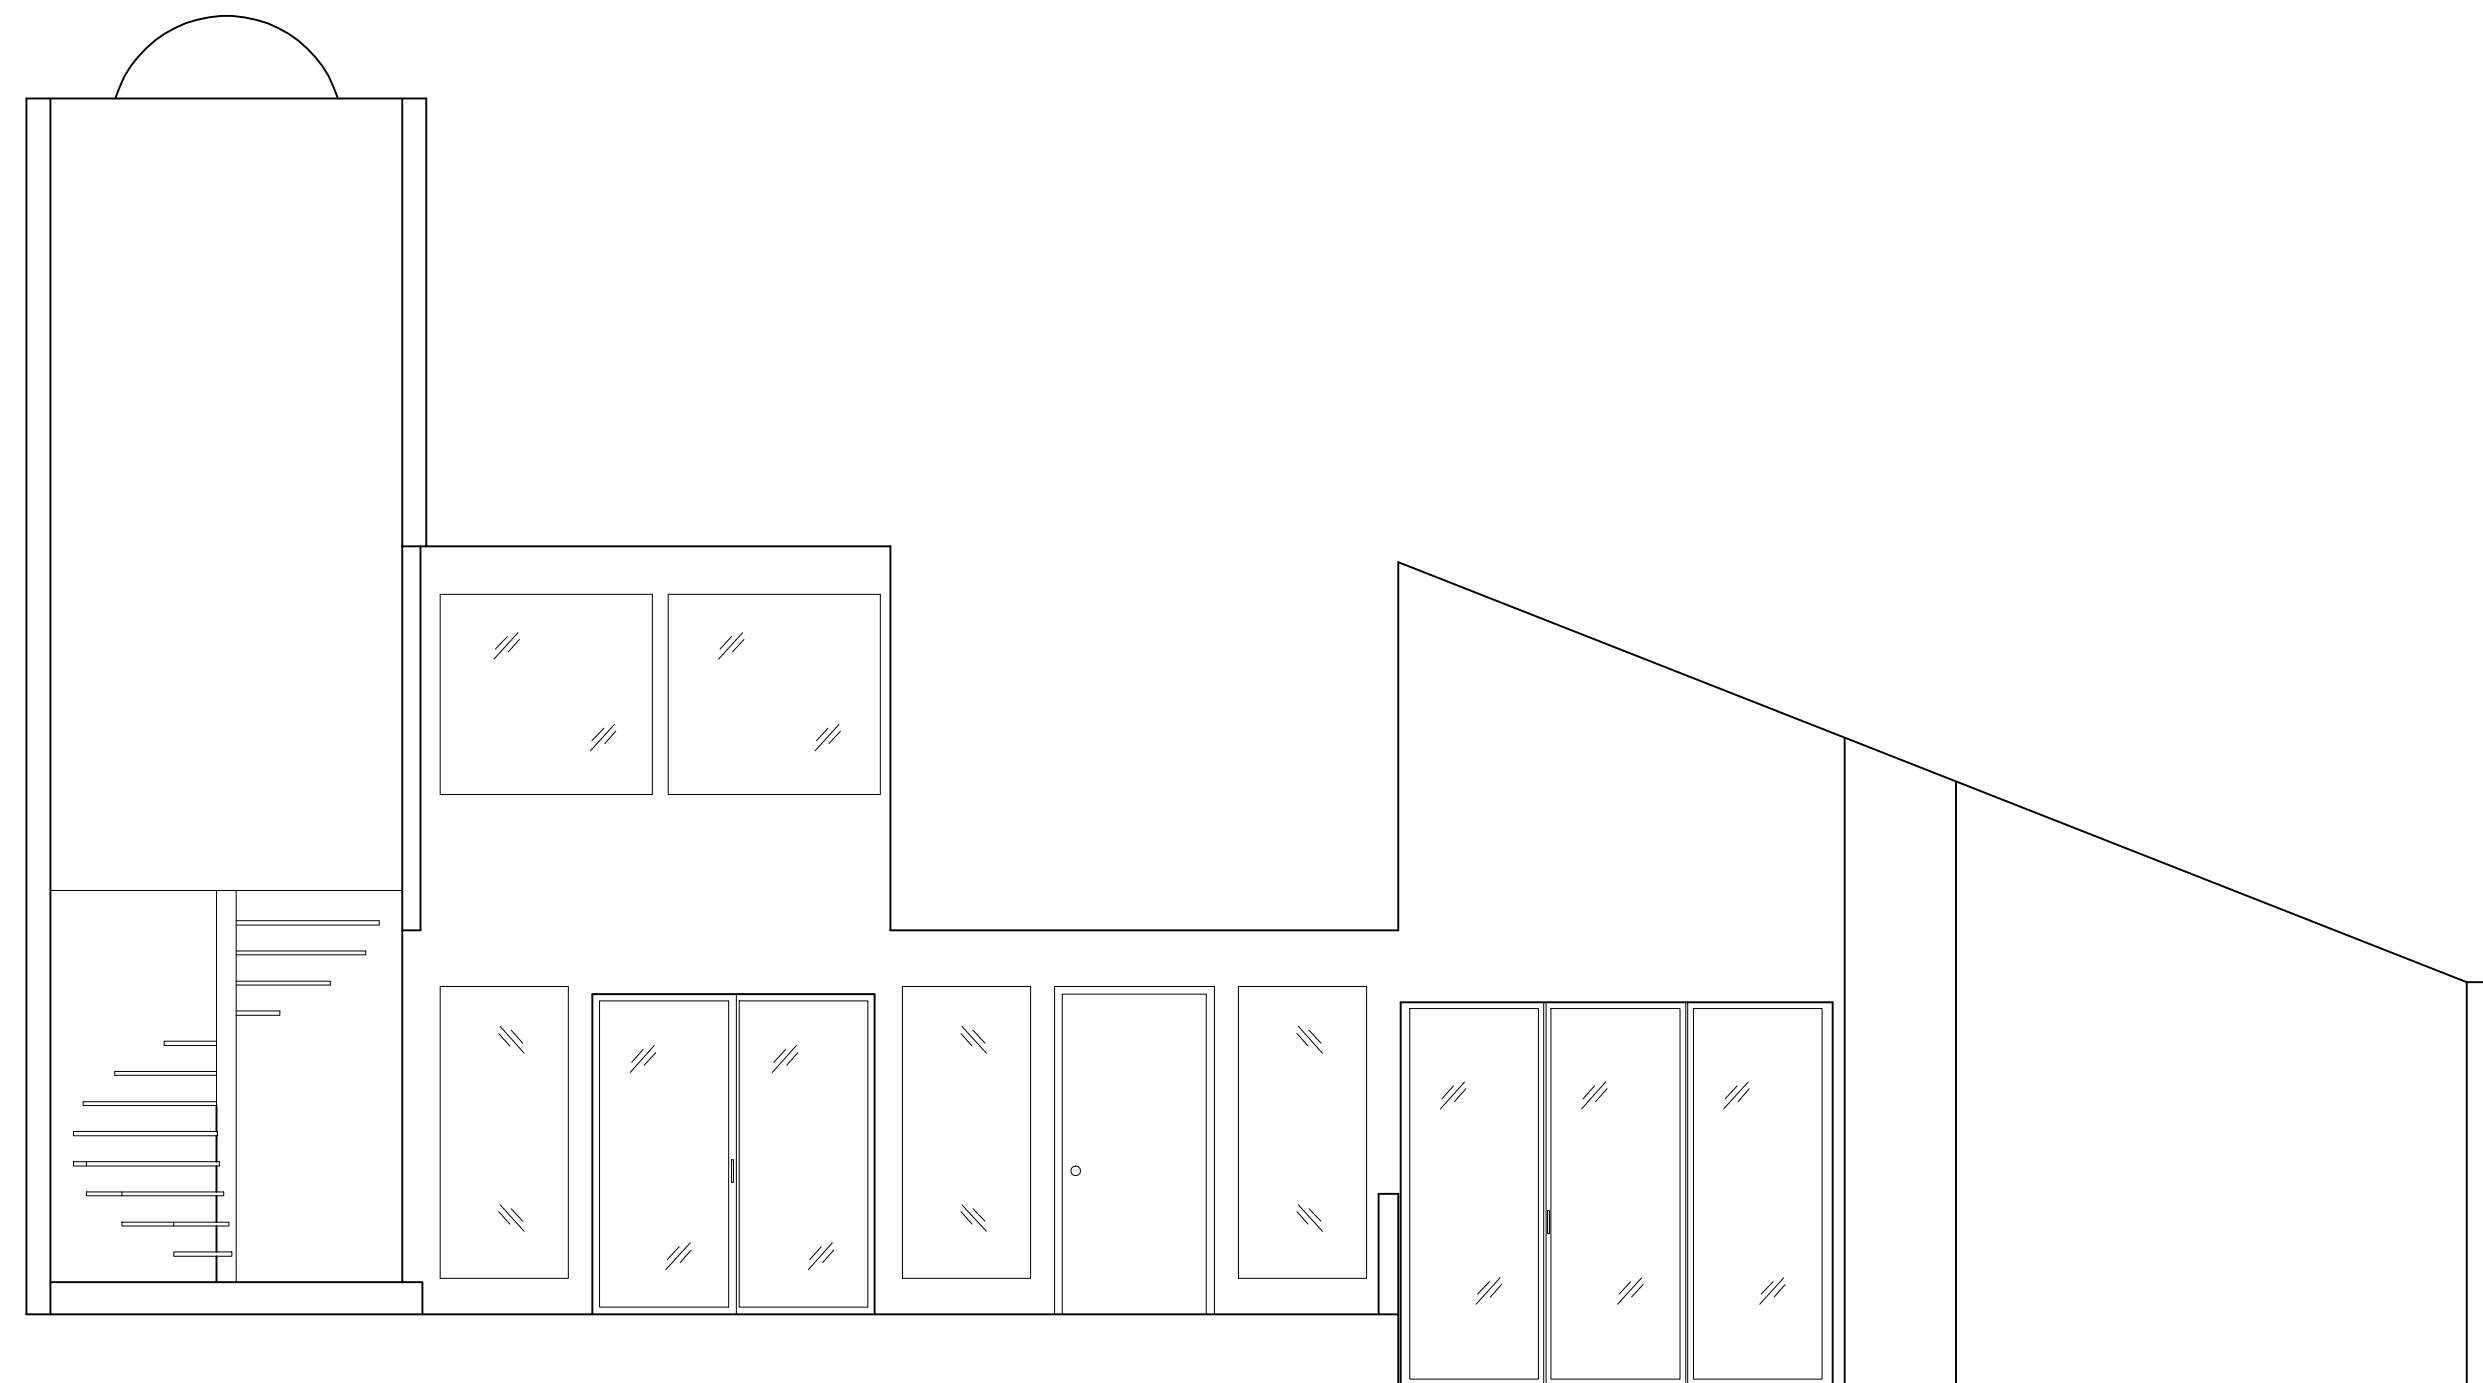AB-5



ARCHITECTURAL AS BUILT

Sag Harbor, NY 11963

01	100% SUBMISSION	
NO.	ISSUES REVISIONS	DATE
		SHEET TITLE
HL		PROJECT MANAGER
HL		PROJECT DIRECTOR
012317-1		PROJECT NUMBER
1/8"=1'-0"		SCALE
CL		DRAWN BY
		SHEET NUMBER