

AS-BUILT DOCUMENTATION


Woodcliff Lake, NJ 07677



100% SUBMITTAL

DRAWING INDEX

- C-1 COVER SHEET | DRAWING INDEX
- SL SYMBOLS LEGEND
- AB-1 BASEMENT AND ENTRY FLOOR PLAN
- AB-2 FIRST FLOOR PLAN
- AB-3 SECOND FLOOR PLAN
- AB-4 THIRD FLOOR PLAN

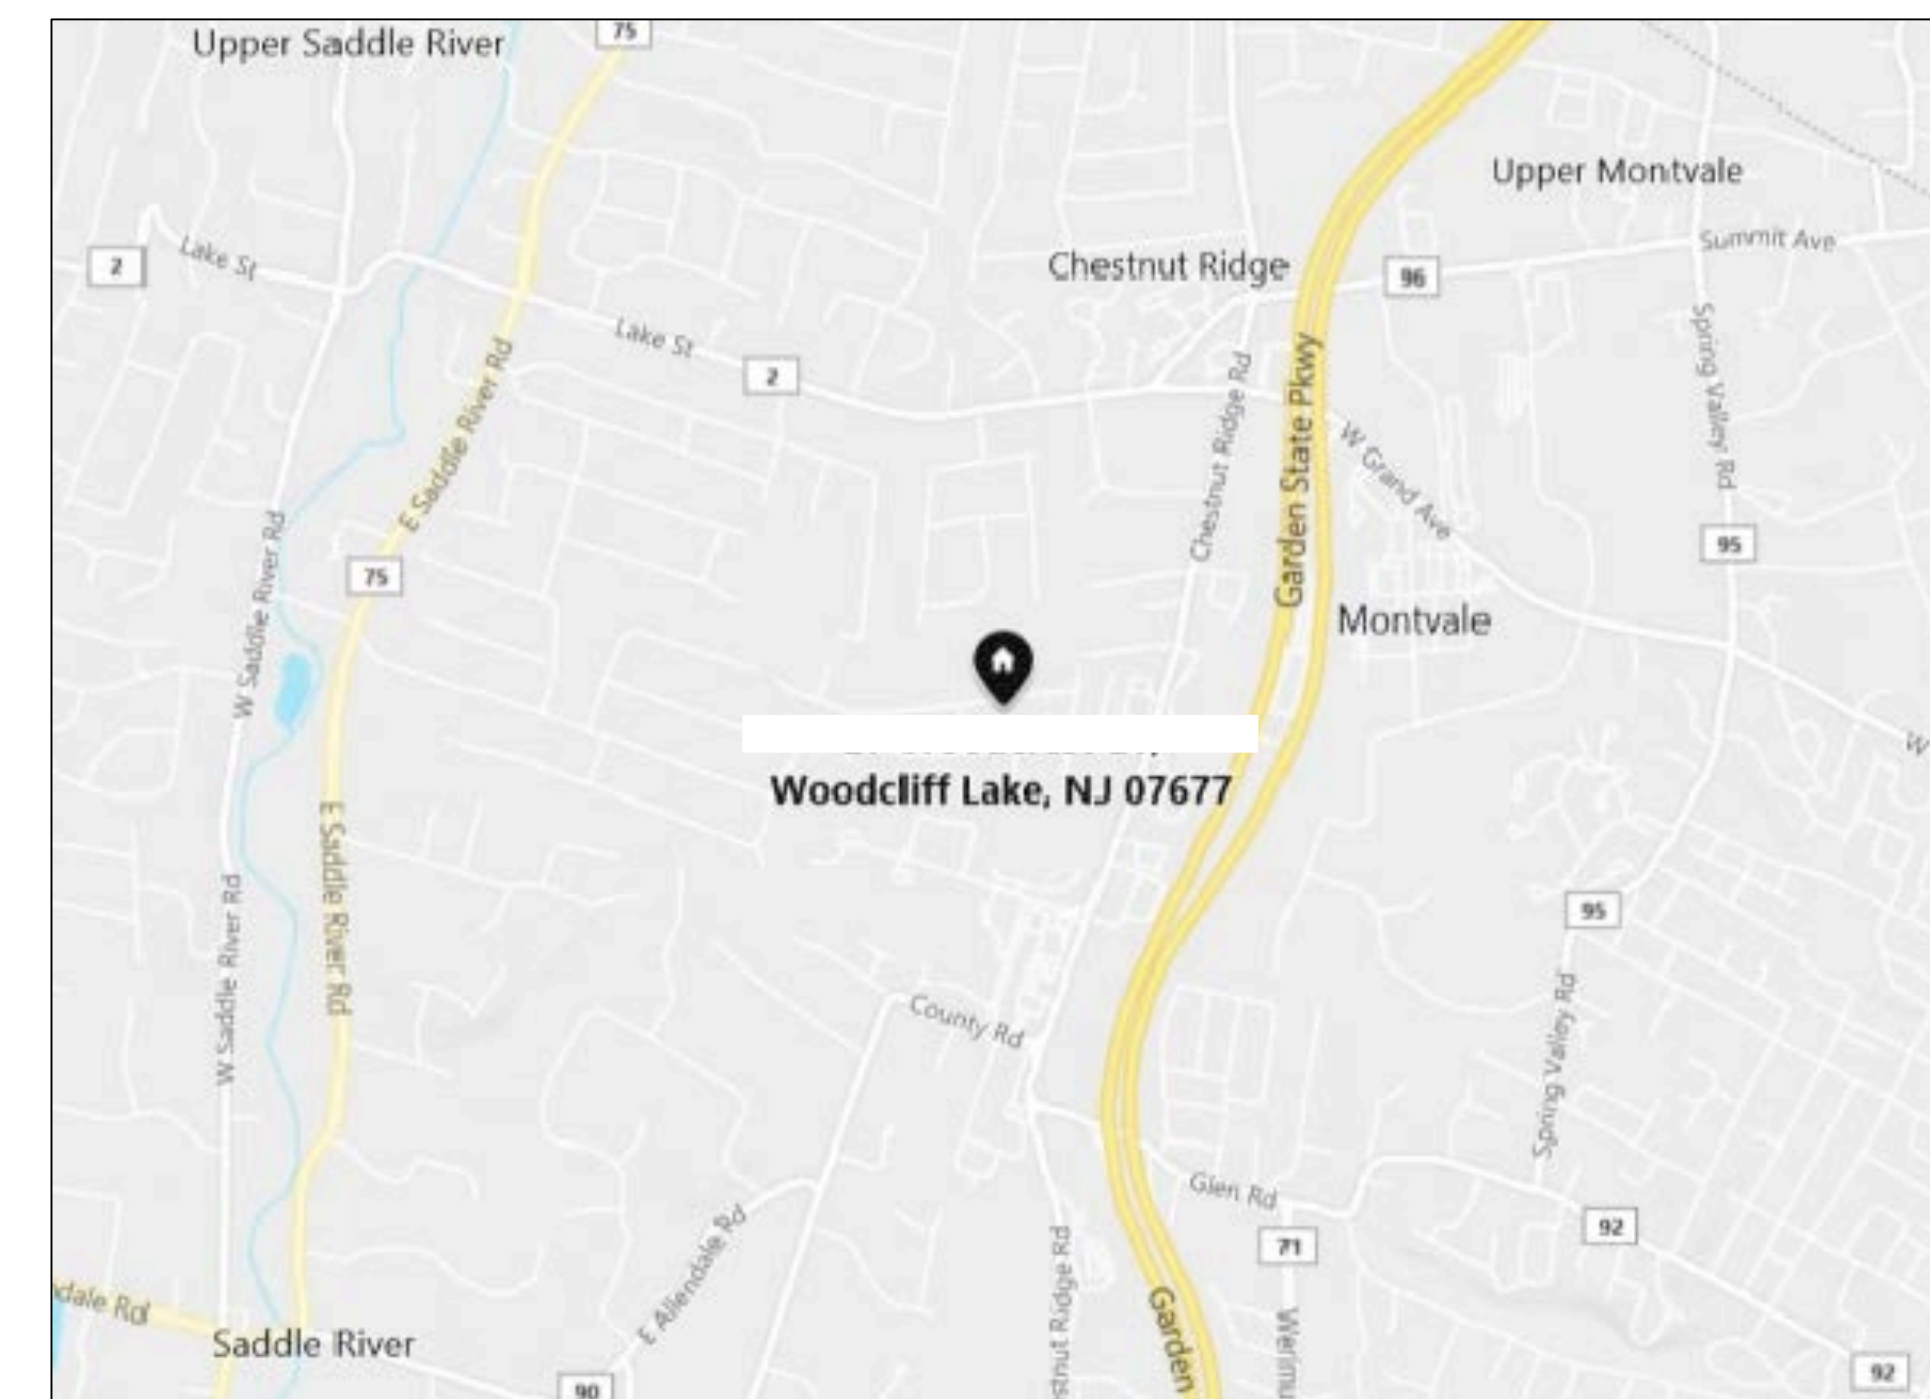

VICINITY MAP
NTS

AREA DATA	
LIVING BASEMENT	671 S.F. ±
ENTRY FLOOR (inc. Garage)	1,006 S.F. ±
LIVING FIRST FLOOR	925 S.F. ±
LIVING SECOND FLOOR	716 S.F. ±
LIVING THIRD FLOOR	738 S.F. ±
GRAND TOTAL	4,056 S.F. ±



ARCHITECTURAL AS BUILT
Woodcliff Lake, NJ 07677

NO.	ISSUES REVISIONS	DATE
01	100% SUBMISSION	

COVER SHEET

HL	PROJECT MANAGER
HL	PROJECT DIRECTOR
012317-1	PROJECT NUMBER
	SCALE
CL	DRAWN BY
	SHEET NUMBER

C-1

SYMBOLS LEGEND

RCP

	EXHAUST VENT		TRACK LIGHT OR VANITY LIGHT
	CEILING MOUNTED LIGHT FIXTURE		WALL-MOUNTED LIGHT FIXTURE
	CEILING MOUNTED DIRECTIONAL LIGHT		EMERGENCY EXIT SIGN
	RECESSED CAN LIGHT		EMERGENCY EXIT LIGHT
	EYEBALL OR SMALL CAN LIGHT		EMERGENCY EXIT LIGHT W/ SIGN
	PENDANT LIGHT		LIGHTED STAIR SIGN
	INDIVIDUAL FLUOR. LAY-IN FIXTURE 4 BULB		FLOOD LIGHT
	INDIVIDUAL FLUOR. HANGING FIXTURE 2 BULB		PHOTO CELL
	INDIVIDUAL FLUOR. FLUSH MOUNT FIXTURE 4 BULB		CEILING FAN
	CAMERA		CEILING FAN W/ LIGHT KIT
	MOTION DET.	7-2-6	CEILING HEIGHT AND TRIM 7'-2" ABOVE FLOOR BELOW WITH 6" CROWN MOULDING. NOTE: ALL CEILINGS NOT LABELED ARE PLASTER. CEILINGS SHOWN WITH A GRID ARE LAY IN ACOUSTICAL TILE..
	SUPPLY VENT		JUNCTION BOX
	SUPPLY VENT		
	RETURN VENT		
	RETURN VENT		
	SPEAKER		

ELECTRIC

	DATA OUTLET
	TELEPHONE JACK
	ELECTRIC SWITCH
	CABLE TELEVISION OUTLET
	DUPLEX RECEPTACLE OUTLET
	SPECIAL PURPOSE CONNECTION OR OUTLET
	QUADRUPLEX RECEPTACLE OUTLET
	FLOOR DUPLEX RECEPTACLE OUTLET
	ELECTRIC PANEL
	ELECTRIC METER
	BUTTON SWITCH
	DISCONNECT SWITCH
	GROUND/FLOOR LIGHT
	KEY PAD

FIRE PROTECTION

	FIRE EXTINGUISHER
	FIRE PULL
	FIRE ALARM (HORN/SRTO)
	SMOKE DETECTOR
	SMOKE ALARM SPEAKER
	SPRINKLER HEAD CEILING MOUNT
	SPRINKLER HEAD WALL MOUNT

MEP

	THERMOSTAT
	FLOOR DRAIN
	VALVE
	HOSE BIB
	WATER SUPPLY
	SUSPENDED GAS HEATER

MISC

	BOLLARD
	SPOT ELEVATION

7-2-6 CEILING HEIGHT AND TRIM 7'-2" ABOVE FLOOR BELOW WITH 6" CROWN MOULDING. NOTE: ALL CEILINGS NOT LABELED ARE PLASTER. CEILINGS SHOWN WITH A GRID ARE LAY IN ACOUSTICAL TILE..

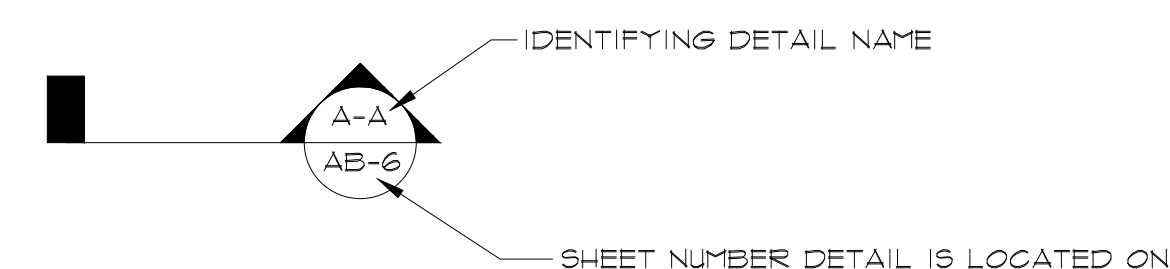
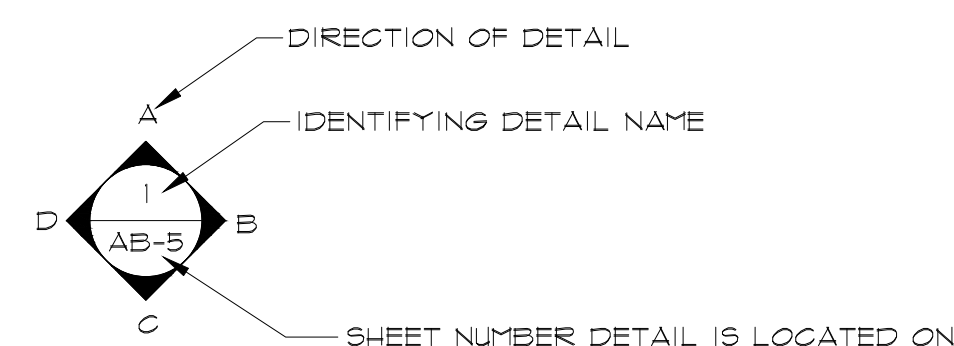


PHOTO DOCUMENTATION LEGEND

INDICATES LOCATION OF CAMERA
 INDICATES DIRECTION OF CAMERA LENS AND CORRESPONDING PHOTO / VIDEO NUMBER

TYPES OF DOCUMENTATION

	001		V-001		323				
GROUND BASED PHOTO		GROUND BASED VIDEO		360° SPHERICAL PHOTO		AERIAL BASED PHOTO		AERIAL BASED VIDEO	


01	100% SUBMISSION	
NO.	ISSUES REVISIONS	DATE
		SHEET TITLE

HL	PROJECT MANAGER
HL	PROJECT DIRECTOR
012317-1	PROJECT NUMBER
NOT TO SCALE	SCALE
CL	DRAWN BY
	SHEET NUMBER


SL

ARCHITECTURAL AS BUILT
Woodcliff Lake, NJ 07677

ARCHITECTURAL AS BUILT
Woodcliff Lake, NJ 07677

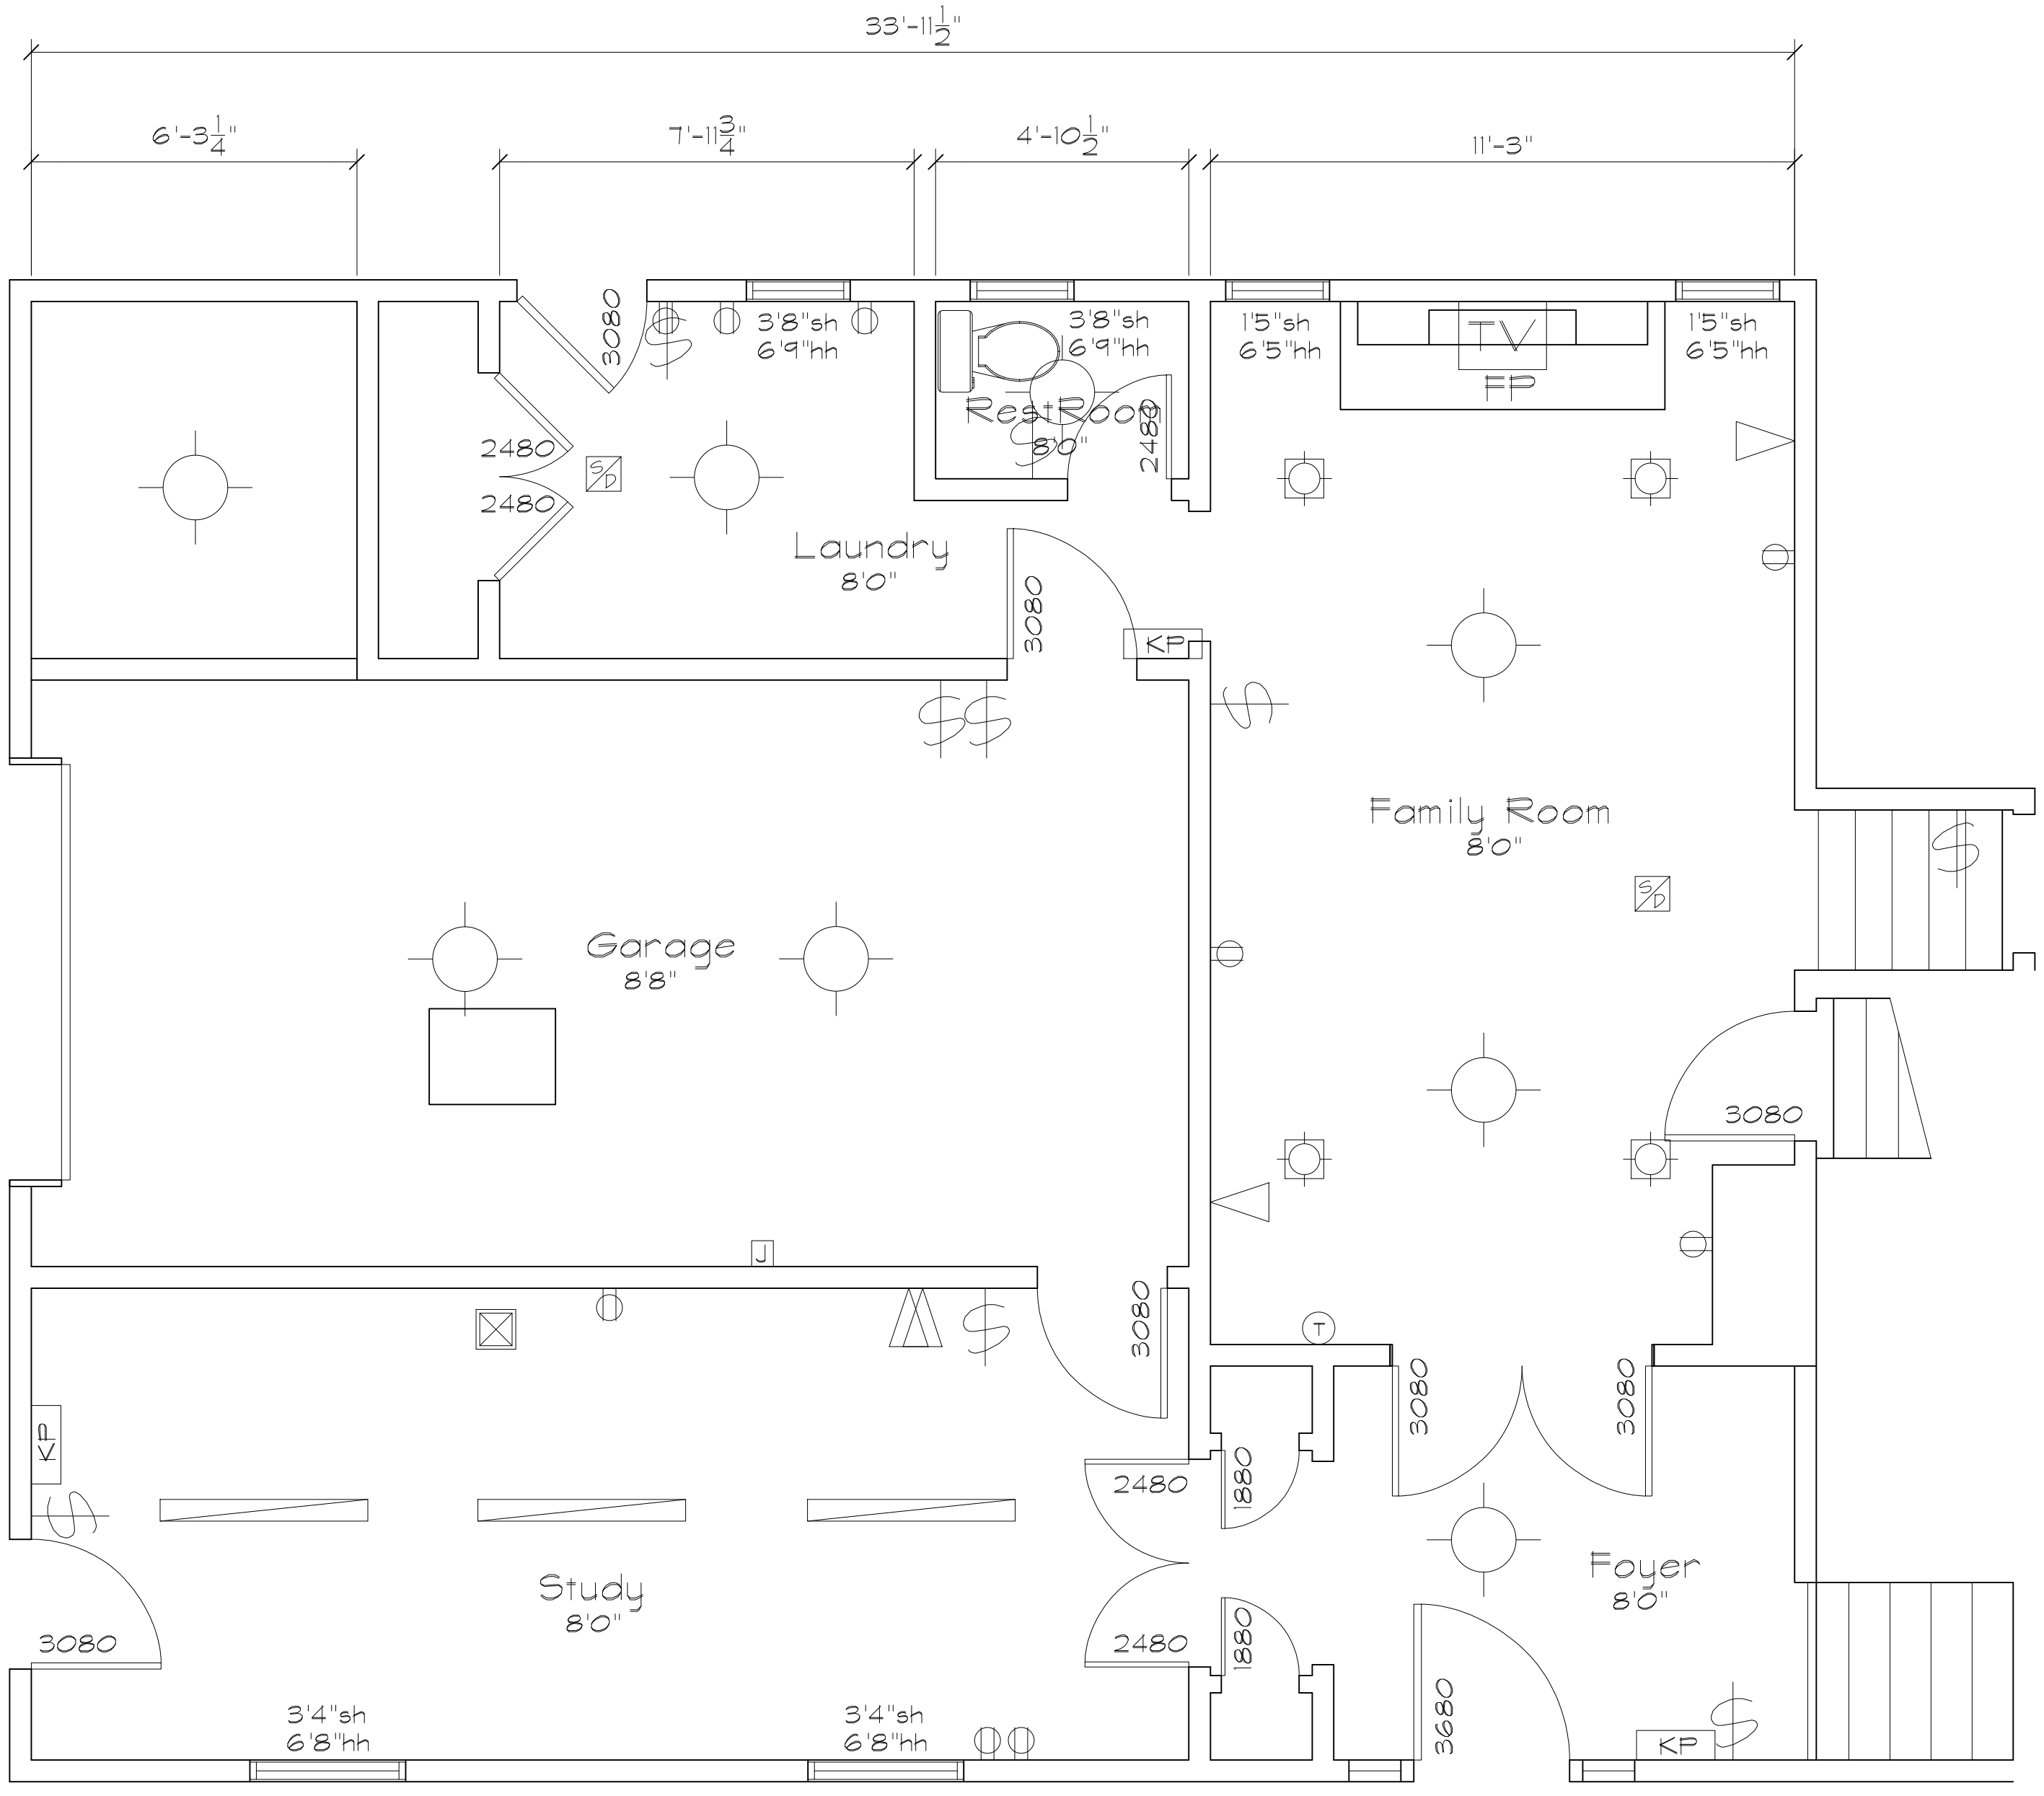


ENTRY LEVEL FLOOR PLAN

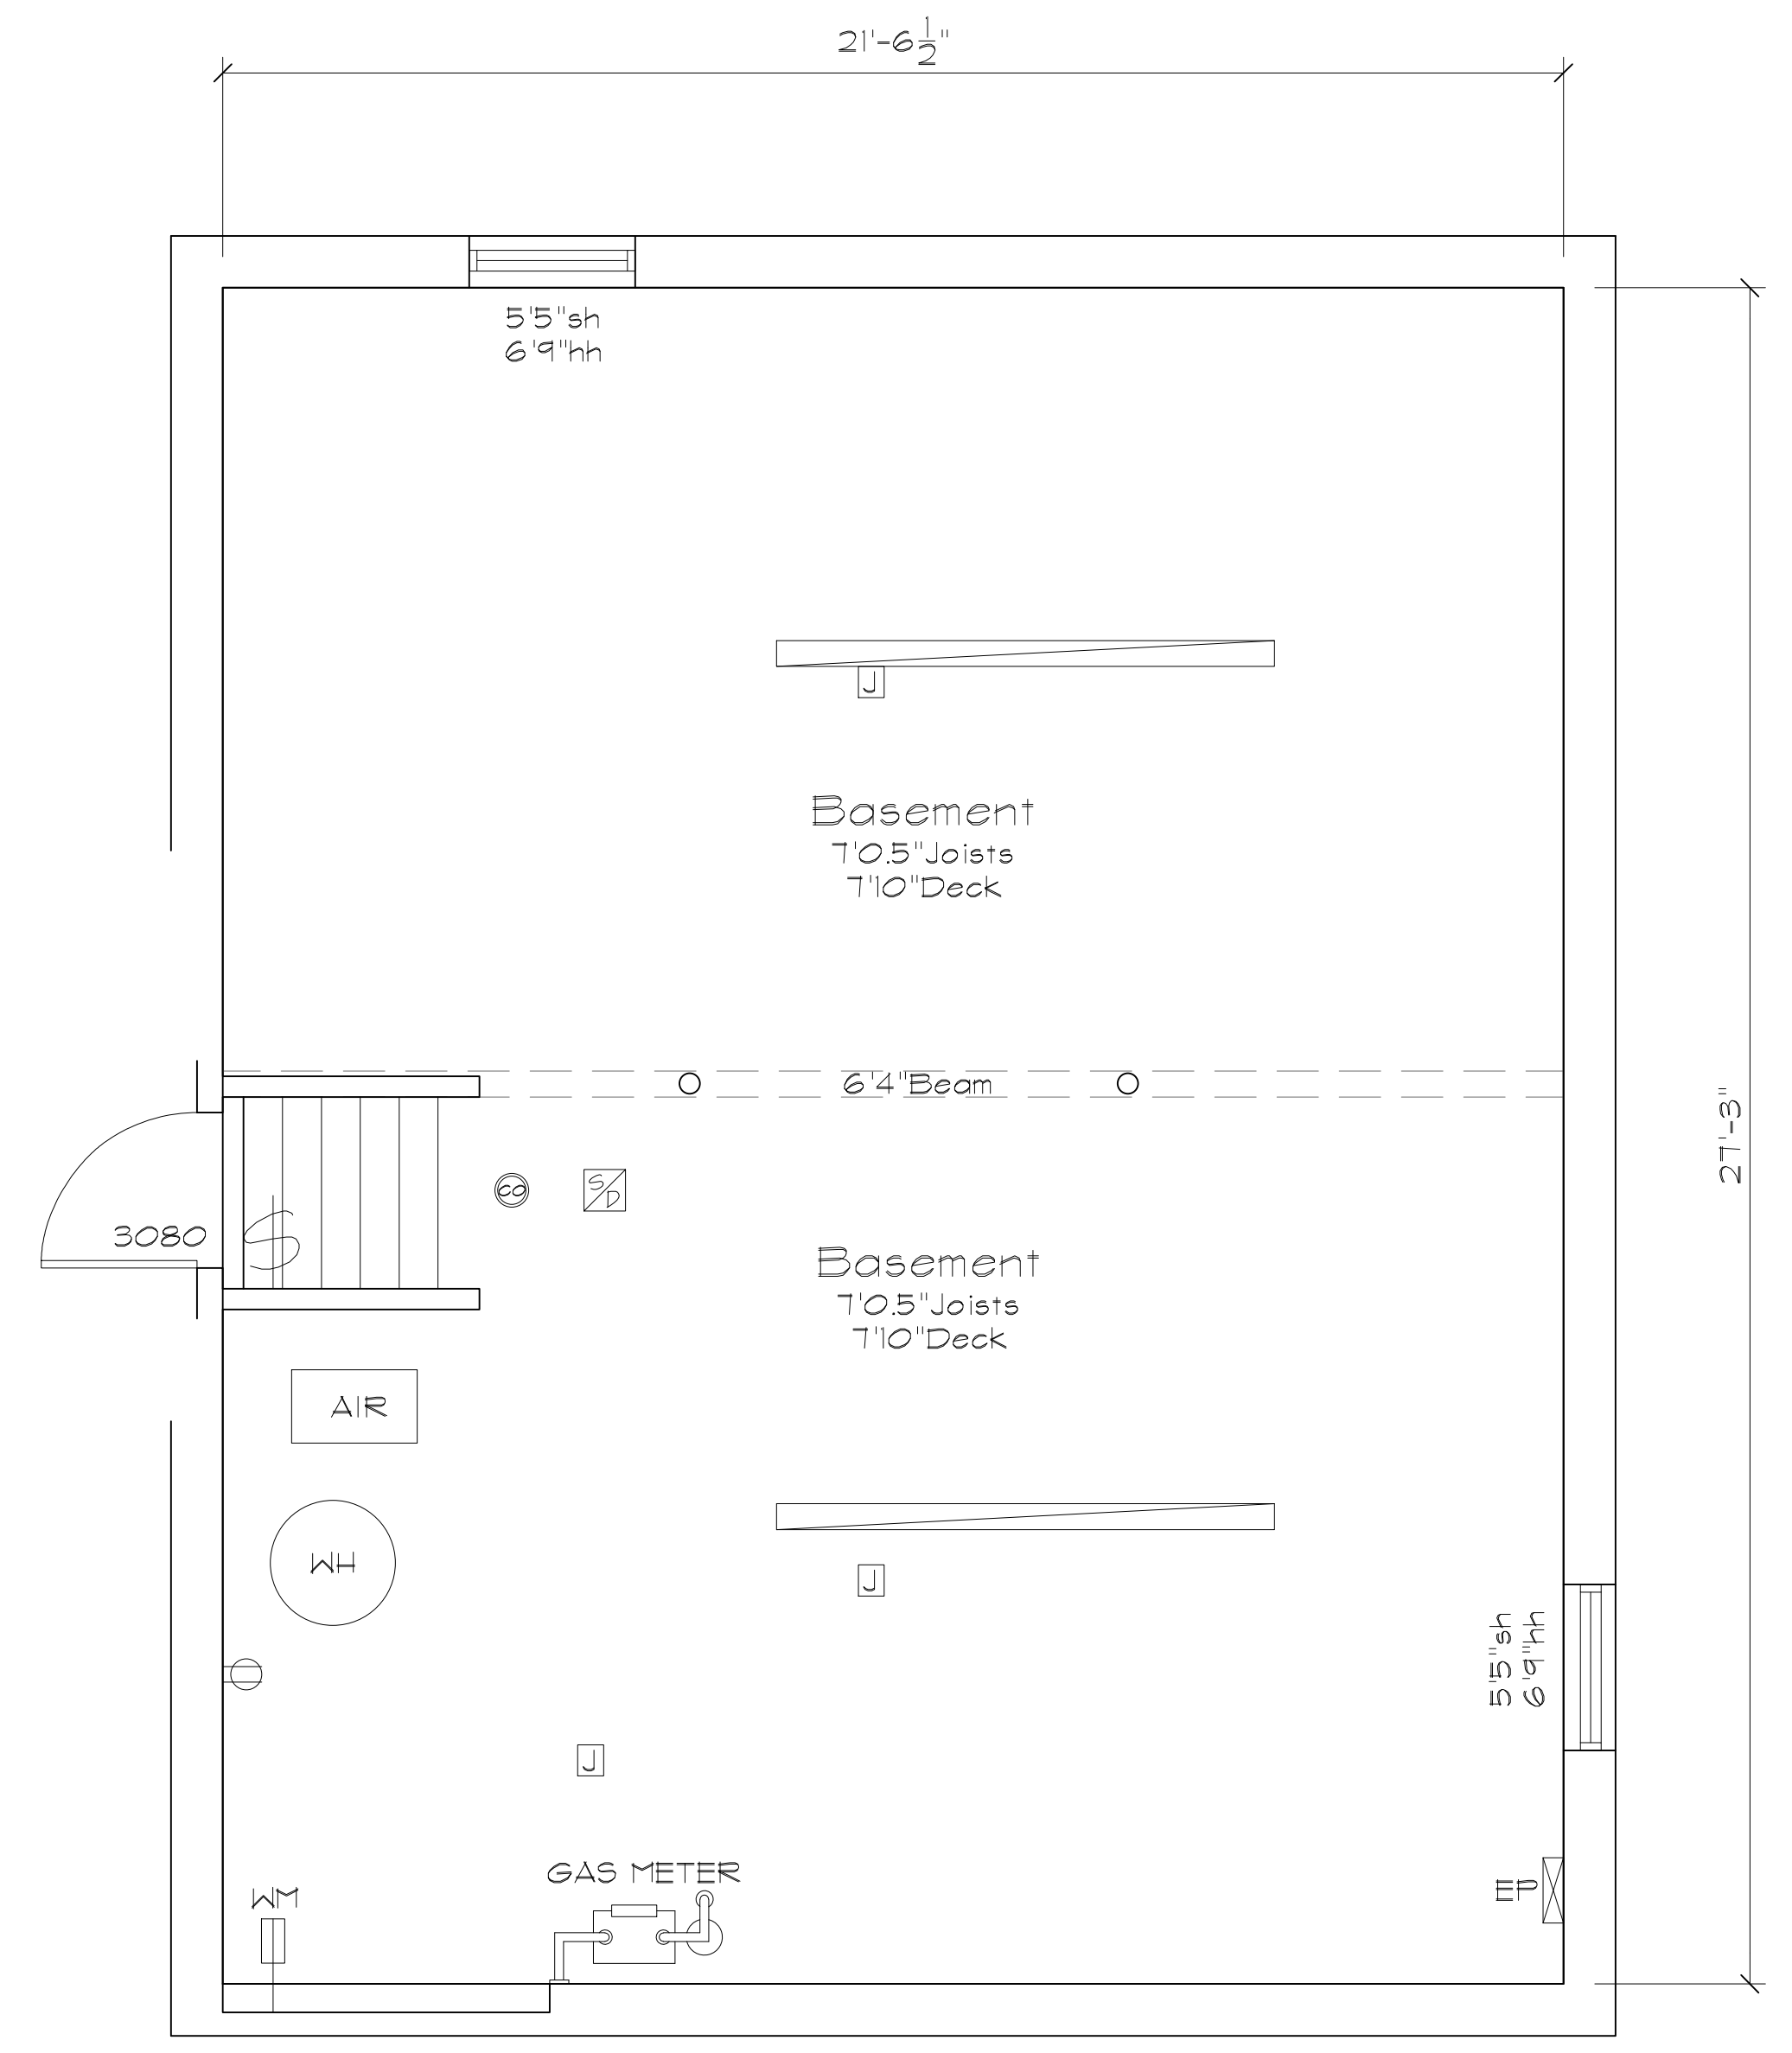

BASEMENT FLOOR PLAN

01	100% SUBMISSION	
NO.	ISSUES REVISIONS	DATE
SHEET TITLE		
HL		PROJECT MANAGER
HL		PROJECT DIRECTOR
012317-1		PROJECT NUMBER
3/8"=1'-0"		SCALE
CL		DRAWN BY
		SHEET NUMBER

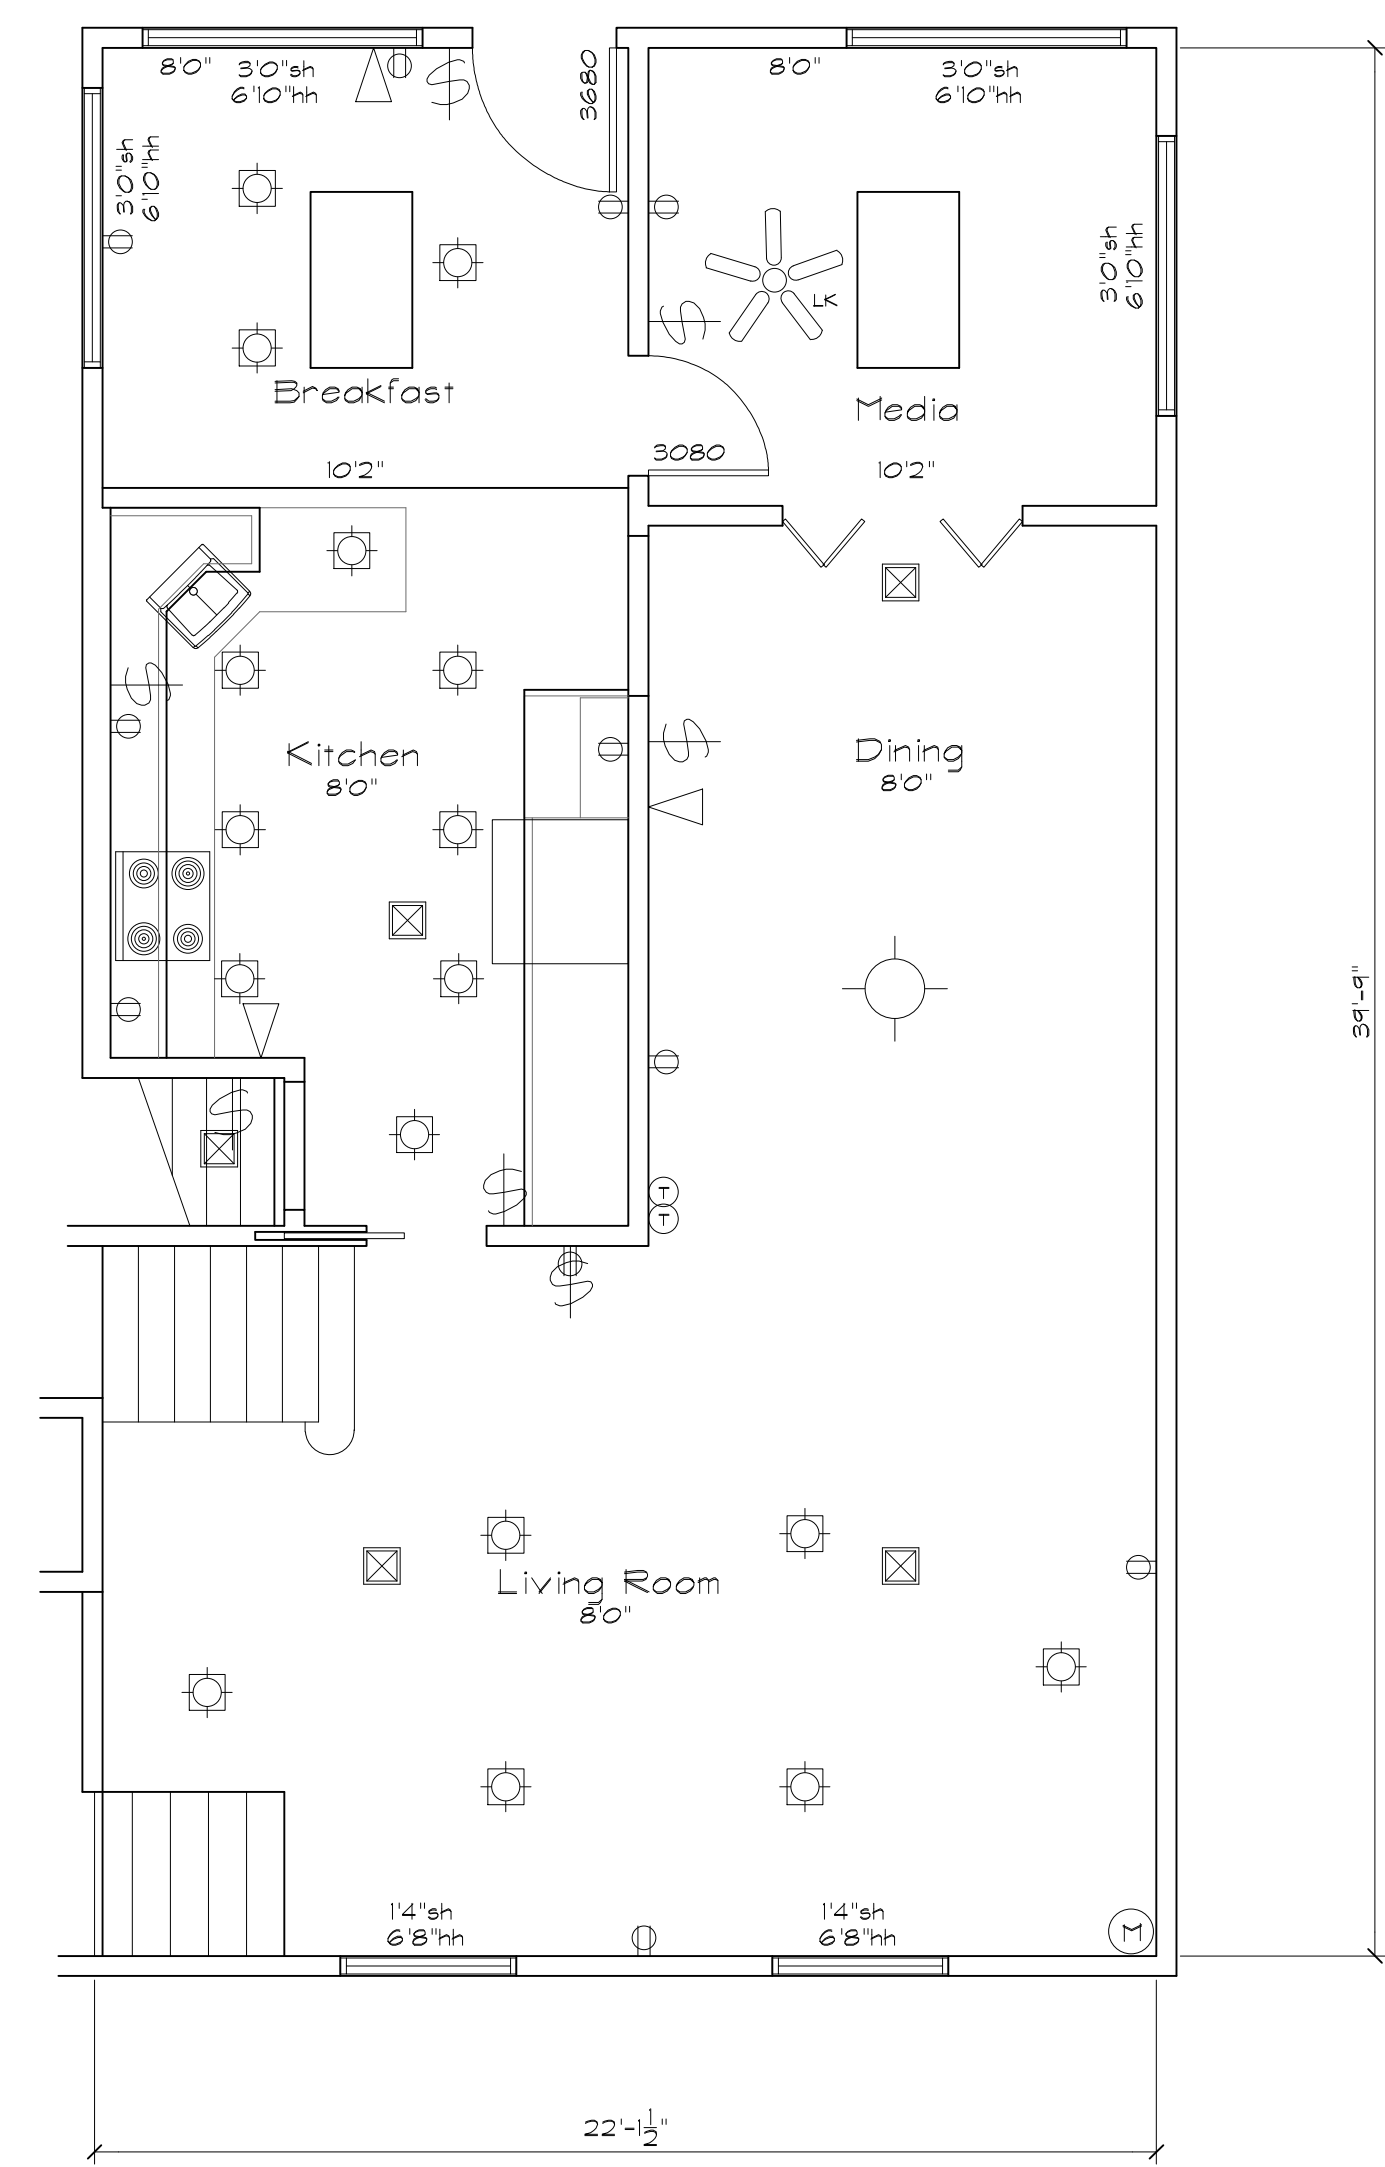

FIRST FLOOR PLAN

ARCHITECTURAL AS BUILT
Woodcliff Lake, NJ 07677

NO.	ISSUES REVISIONS	DATE
01	100% SUBMISSION	

SHEET TITLE

HL PROJECT MANAGER

HL PROJECT DIRECTOR


012317-1 PROJECT NUMBER

1/4"=1'-0" SCALE

CL DRAWN BY

SHEET NUMBER

AB-2

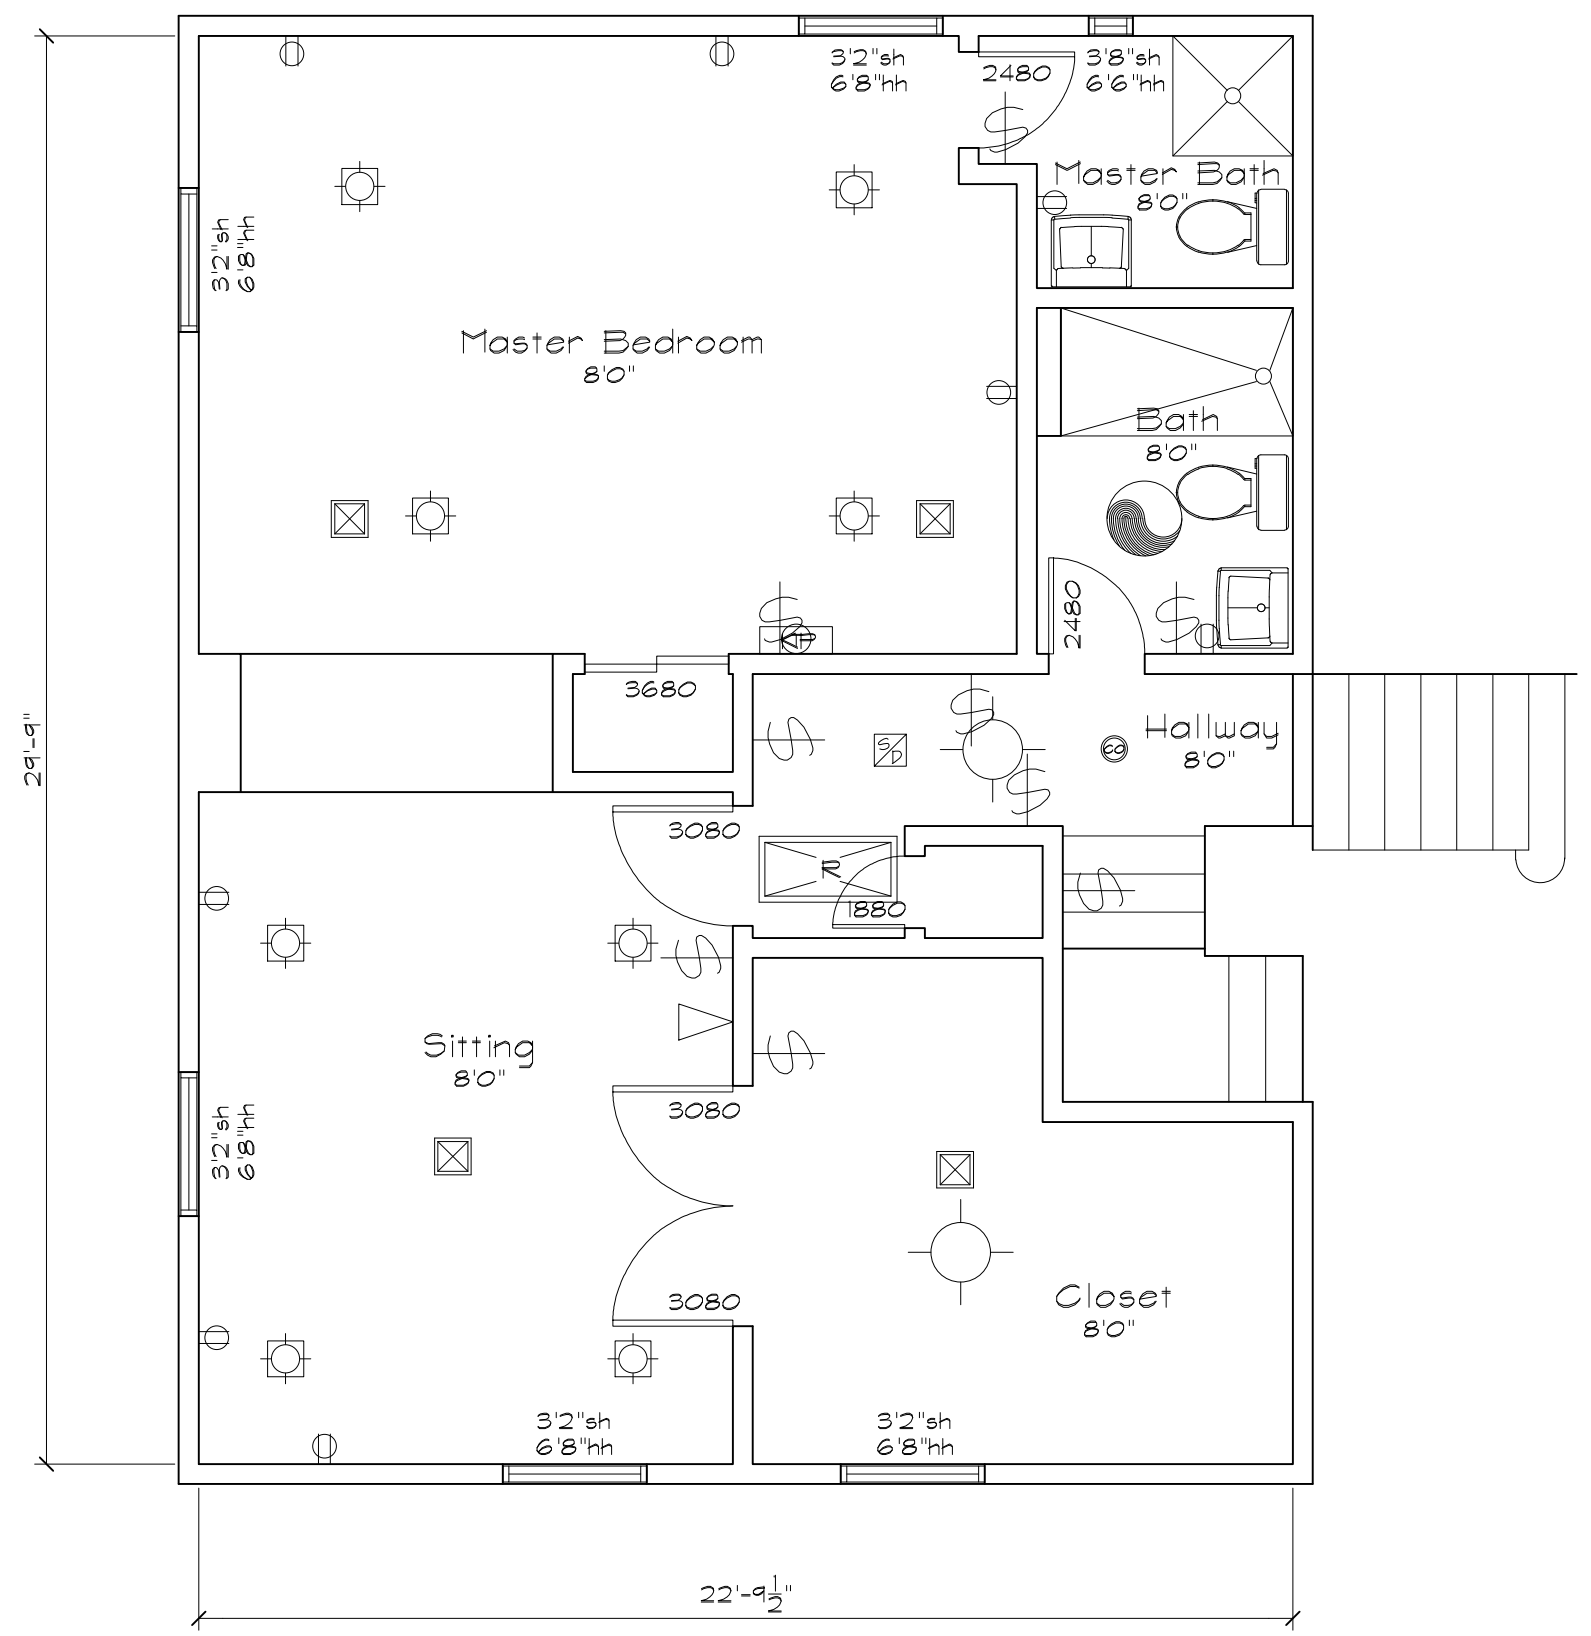


SECOND FLOOR PLAN

ARCHITECTURAL AS BUILT
Woodcliff Lake, NJ 07677

01	100% SUBMISSION	
NO.	ISSUES REVISIONS	DATE
SHEET TITLE		
HL	PROJECT MANAGER	
HL	PROJECT DIRECTOR	
012317-1	PROJECT NUMBER	
1/4"=1'-0"	SCALE	
CL	DRAWN BY	
	SHEET NUMBER	

AB-3

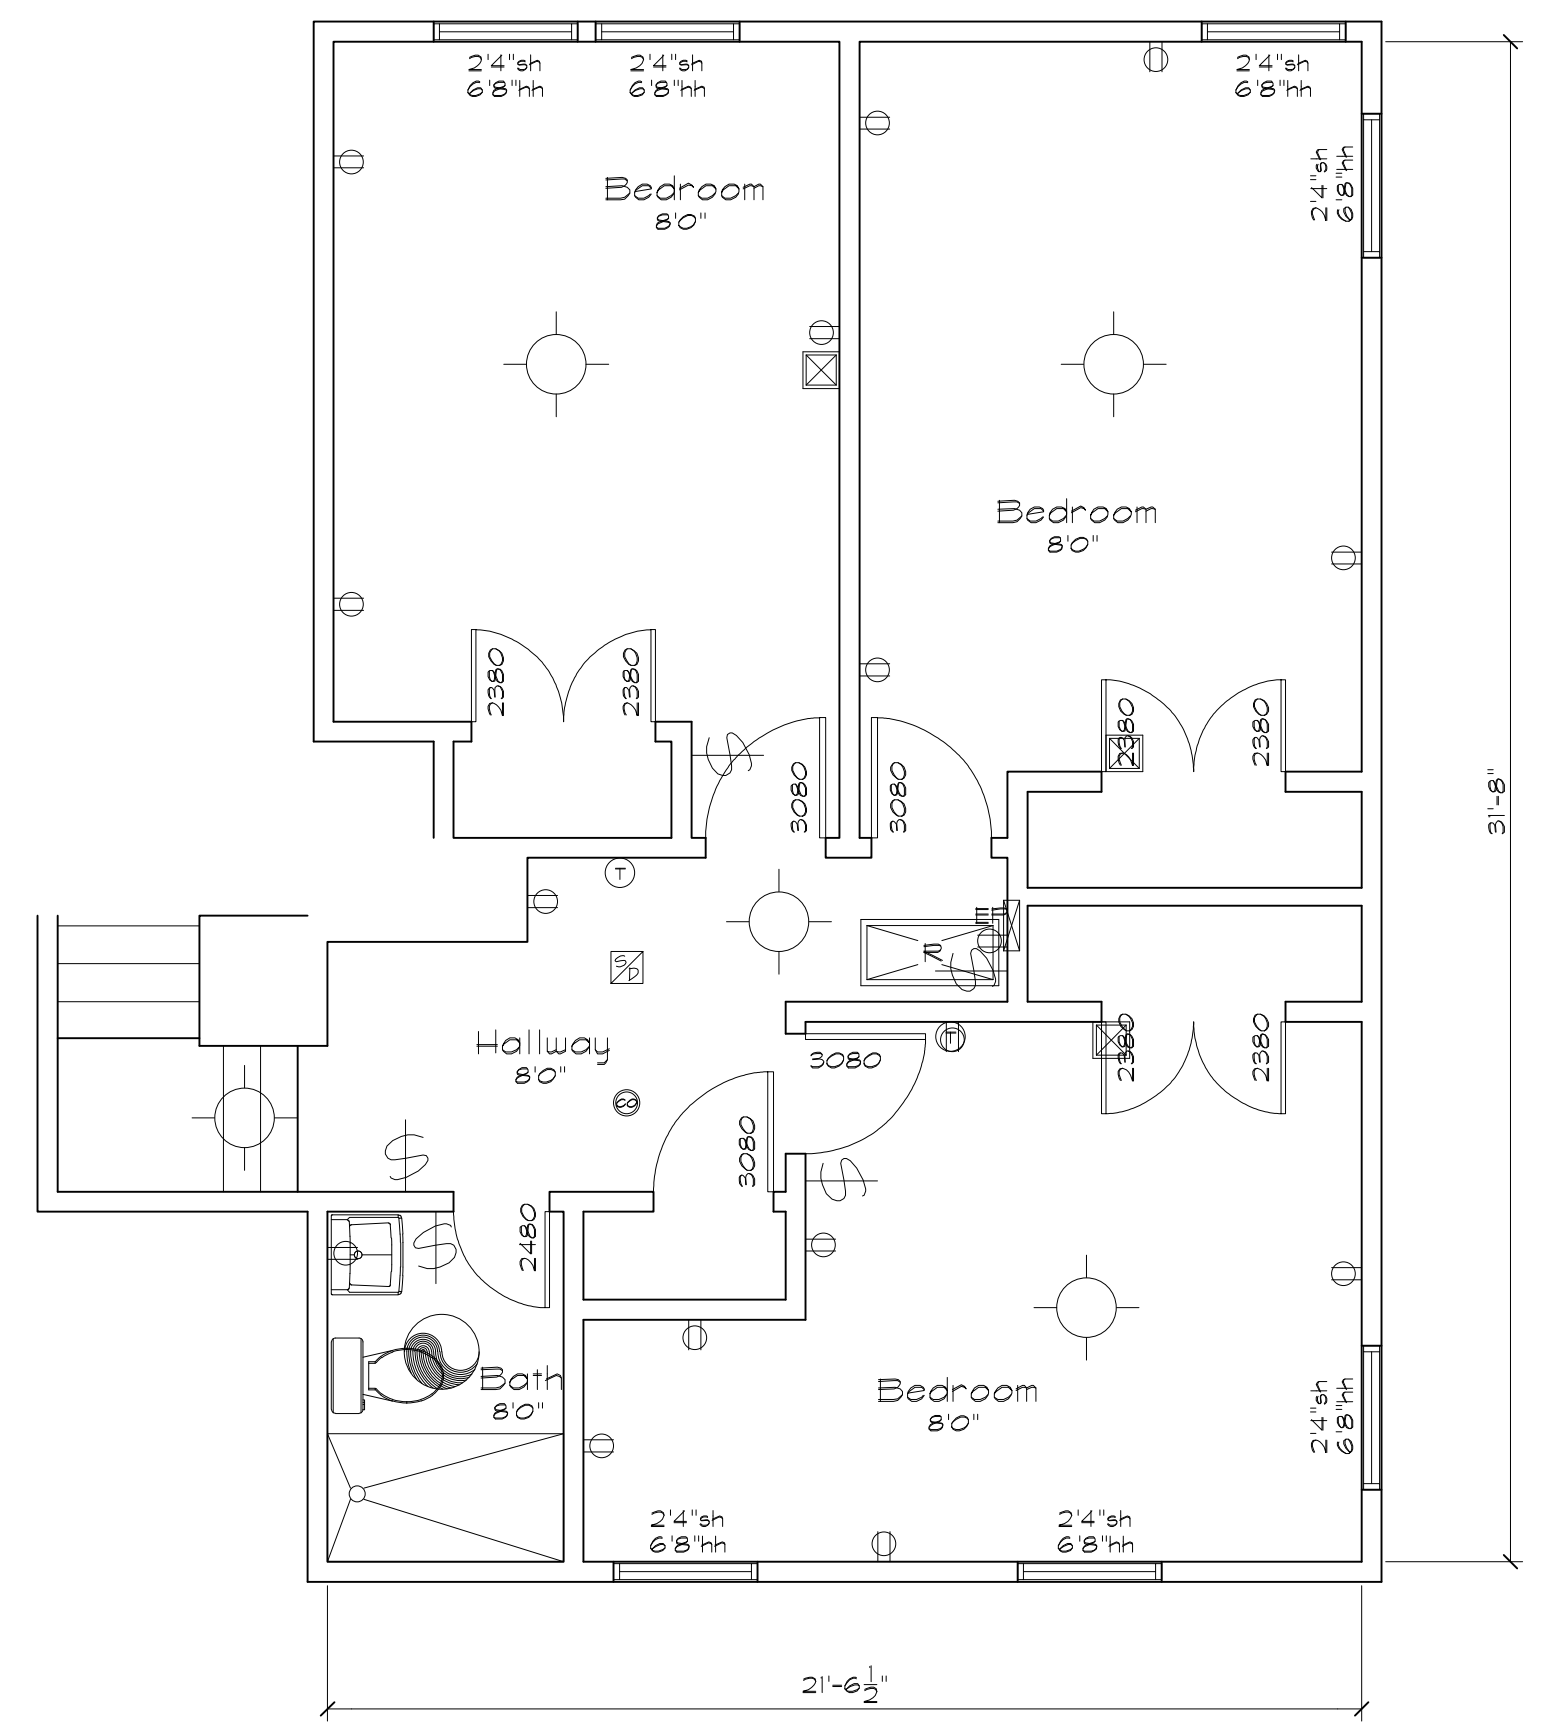

THIRD FLOOR PLAN

ARCHITECTURAL AS BUILT
Woodcliff Lake, NJ 07677

NO.	ISSUES REVISIONS	DATE
01	100% SUBMISSION	

HL	PROJECT MANAGER

HL	PROJECT DIRECTOR

012317-1	PROJECT NUMBER

1/4"=1'-0"	SCALE

CL	DRAWN BY

	SHEET NUMBER

AB-4