

SYMBOLS LEGEND

RCP

- EXHAUST VENT
- CEILING MOUNTED LIGHT FIXTURE
- CEILING MOUNTED DIRECTIONAL LIGHT
- RECESSED CAN LIGHT
- EYEBALL OR SMALL CAN LIGHT
- PENDANT LIGHT
- INDIVIDUAL FLUOR. LAY-IN FIXTURE 4 BULB
- INDIVIDUAL FLUOR. HANGING FIXTURE 2 BULB
- INDIVIDUAL FLUOR. FLUSH MOUNT FIXTURE 4 BULB
- CAMERA
- MOTION DET.
- SUPPLY VENT
- SUPPLY VENT
- RETURN VENT
- RETURN VENT
- SPEAKER

- TRACK LIGHT OR VANITY LIGHT
- WALL-MOUNTED LIGHT FIXTURE
- EMERGENCY EXIT SIGN
- EMERGENCY EXIT LIGHT
- EMERGENCY EXIT LIGHT W/ SIGN
- LIGHTED STAIR SIGN
- FLOOD LIGHT
- PHOTO CELL
- CEILING FAN
- CEILING FAN W/ LIGHT KIT
- JUNCTION BOX

7-2-6 CEILING HEIGHT AND TRIM 7'-2" ABOVE FLOOR BELOW WITH 6" CROWN MOULDING. NOTE: ALL CEILINGS NOT LABELED ARE PLASTER. CEILINGS SHOWN WITH A GRID ARE LAY IN ACOUSTICAL TILE..

ELECTRIC

- DATA OUTLET
- TELEPHONE JACK
- ELECTRIC SWITCH
- CABLE TELEVISION OUTLET
- DUPLEX RECEPTACLE OUTLET
- SPECIAL PURPOSE CONNECTION OR OUTLET
- QUADRUPLEX RECEPTACLE OUTLET
- FLOOR DUPLEX RECEPTACLE OUTLET
- ELECTRIC PANEL
- ELECTRIC METER
- BUTTON SWITCH
- DISCONNECT SWITCH
- GROUND/FLOOR LIGHT
- WALL MOUNTED LIGHT
- KEY PAD

FIRE PROTECTION

- FIRE EXTINGUISHER
- FIRE PULL
- FIRE ALARM (HORN/SRTOBE)
- CARBON MONOXIDE DETECTOR
- SMOKE DETECTOR
- SMOKE ALARM SPEAKER
- SPRINKLER HEAD CEILING MOUNT
- SPRINKLER HEAD WALL MOUNT


MEP

- THERMOSTAT
- FLOOR DRAIN
- VALVE
- HOSE BIB
- WATER SUPPLY
- SUSPENDED GAS HEATER


MISC

- BOLLARD
- 11-4-11/16 SPOT ELEVATION

7-2-6 CEILING HEIGHT AND TRIM 7'-2" ABOVE FLOOR BELOW WITH 6" CROWN MOULDING. NOTE: ALL CEILINGS NOT LABELED ARE PLASTER. CEILINGS SHOWN WITH A GRID ARE LAY IN ACOUSTICAL TILE..

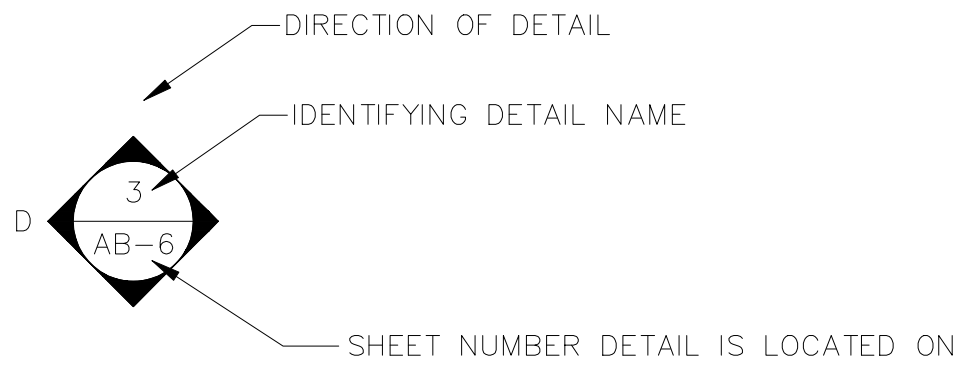

INTERIOR ELEVATIONS

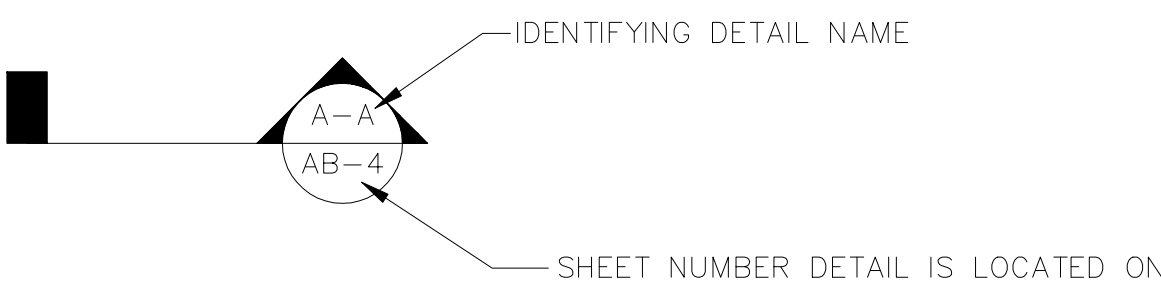

BUILDING SECTIONS

PHOTO DOCUMENTATION LEGEND

- INDICATES LOCATION OF CAMERA
- INDICATES DIRECTION OF CAMERA LENS AND CORRESPONDING PHOTO / VIDEO NUMBER
- TYPES OF DOCUMENTATION
- GROUND BASED PHOTO
- GROUND BASED VIDEO
- 360° SHPERICAL PHOTO
- AERIAL BASED PHOTO
- AERIAL BASED VIDEO

As BUILT

PROFESSIONALS

www.asbultprofessionals.com

A DIVISION OF:

AEC

CONSULTANTS INC

844.272.8458

844 A S B U I L T

© 2020 AEC CONSULTANTS INC

ARCHITECTURAL AS BUILT
Limelight Hotel
Aspen, CO 81611

SYMBOLS LEGEND

HL	PROJECT MANAGER
HL	PROJECT DIRECTOR
012317-1	PROJECT NUMBER
NOT TO SCALE	SCALE
BB	DRAWN BY
SL	SHEET NUMBER



AS BUILT
PROFESSIONALS

www.asbuiltprofessionals.com

A DIVISION OF:



AEC

— □ —

CONSULTANTS INC


844.272.8458
844 A S BUILT

© 2020 AEC CONSULTANTS INC

ARCHITECTURAL AS BUILT
Limelight Hotel
Aspen, CO 81611

01	100% SUBMISSION	11/16/2020
NO.	ISSUES REVISIONS	DATE
		SHEET TITLE
1ST FLOOR PLAN		
HL	PROJECT MANAGER	
HL	PROJECT DIRECTOR	
012317-1	PROJECT NUMBER	
1/8"=1'-0"		SCALE
BB	DRAWN BY	
		SHEET NUMBER

AB-1

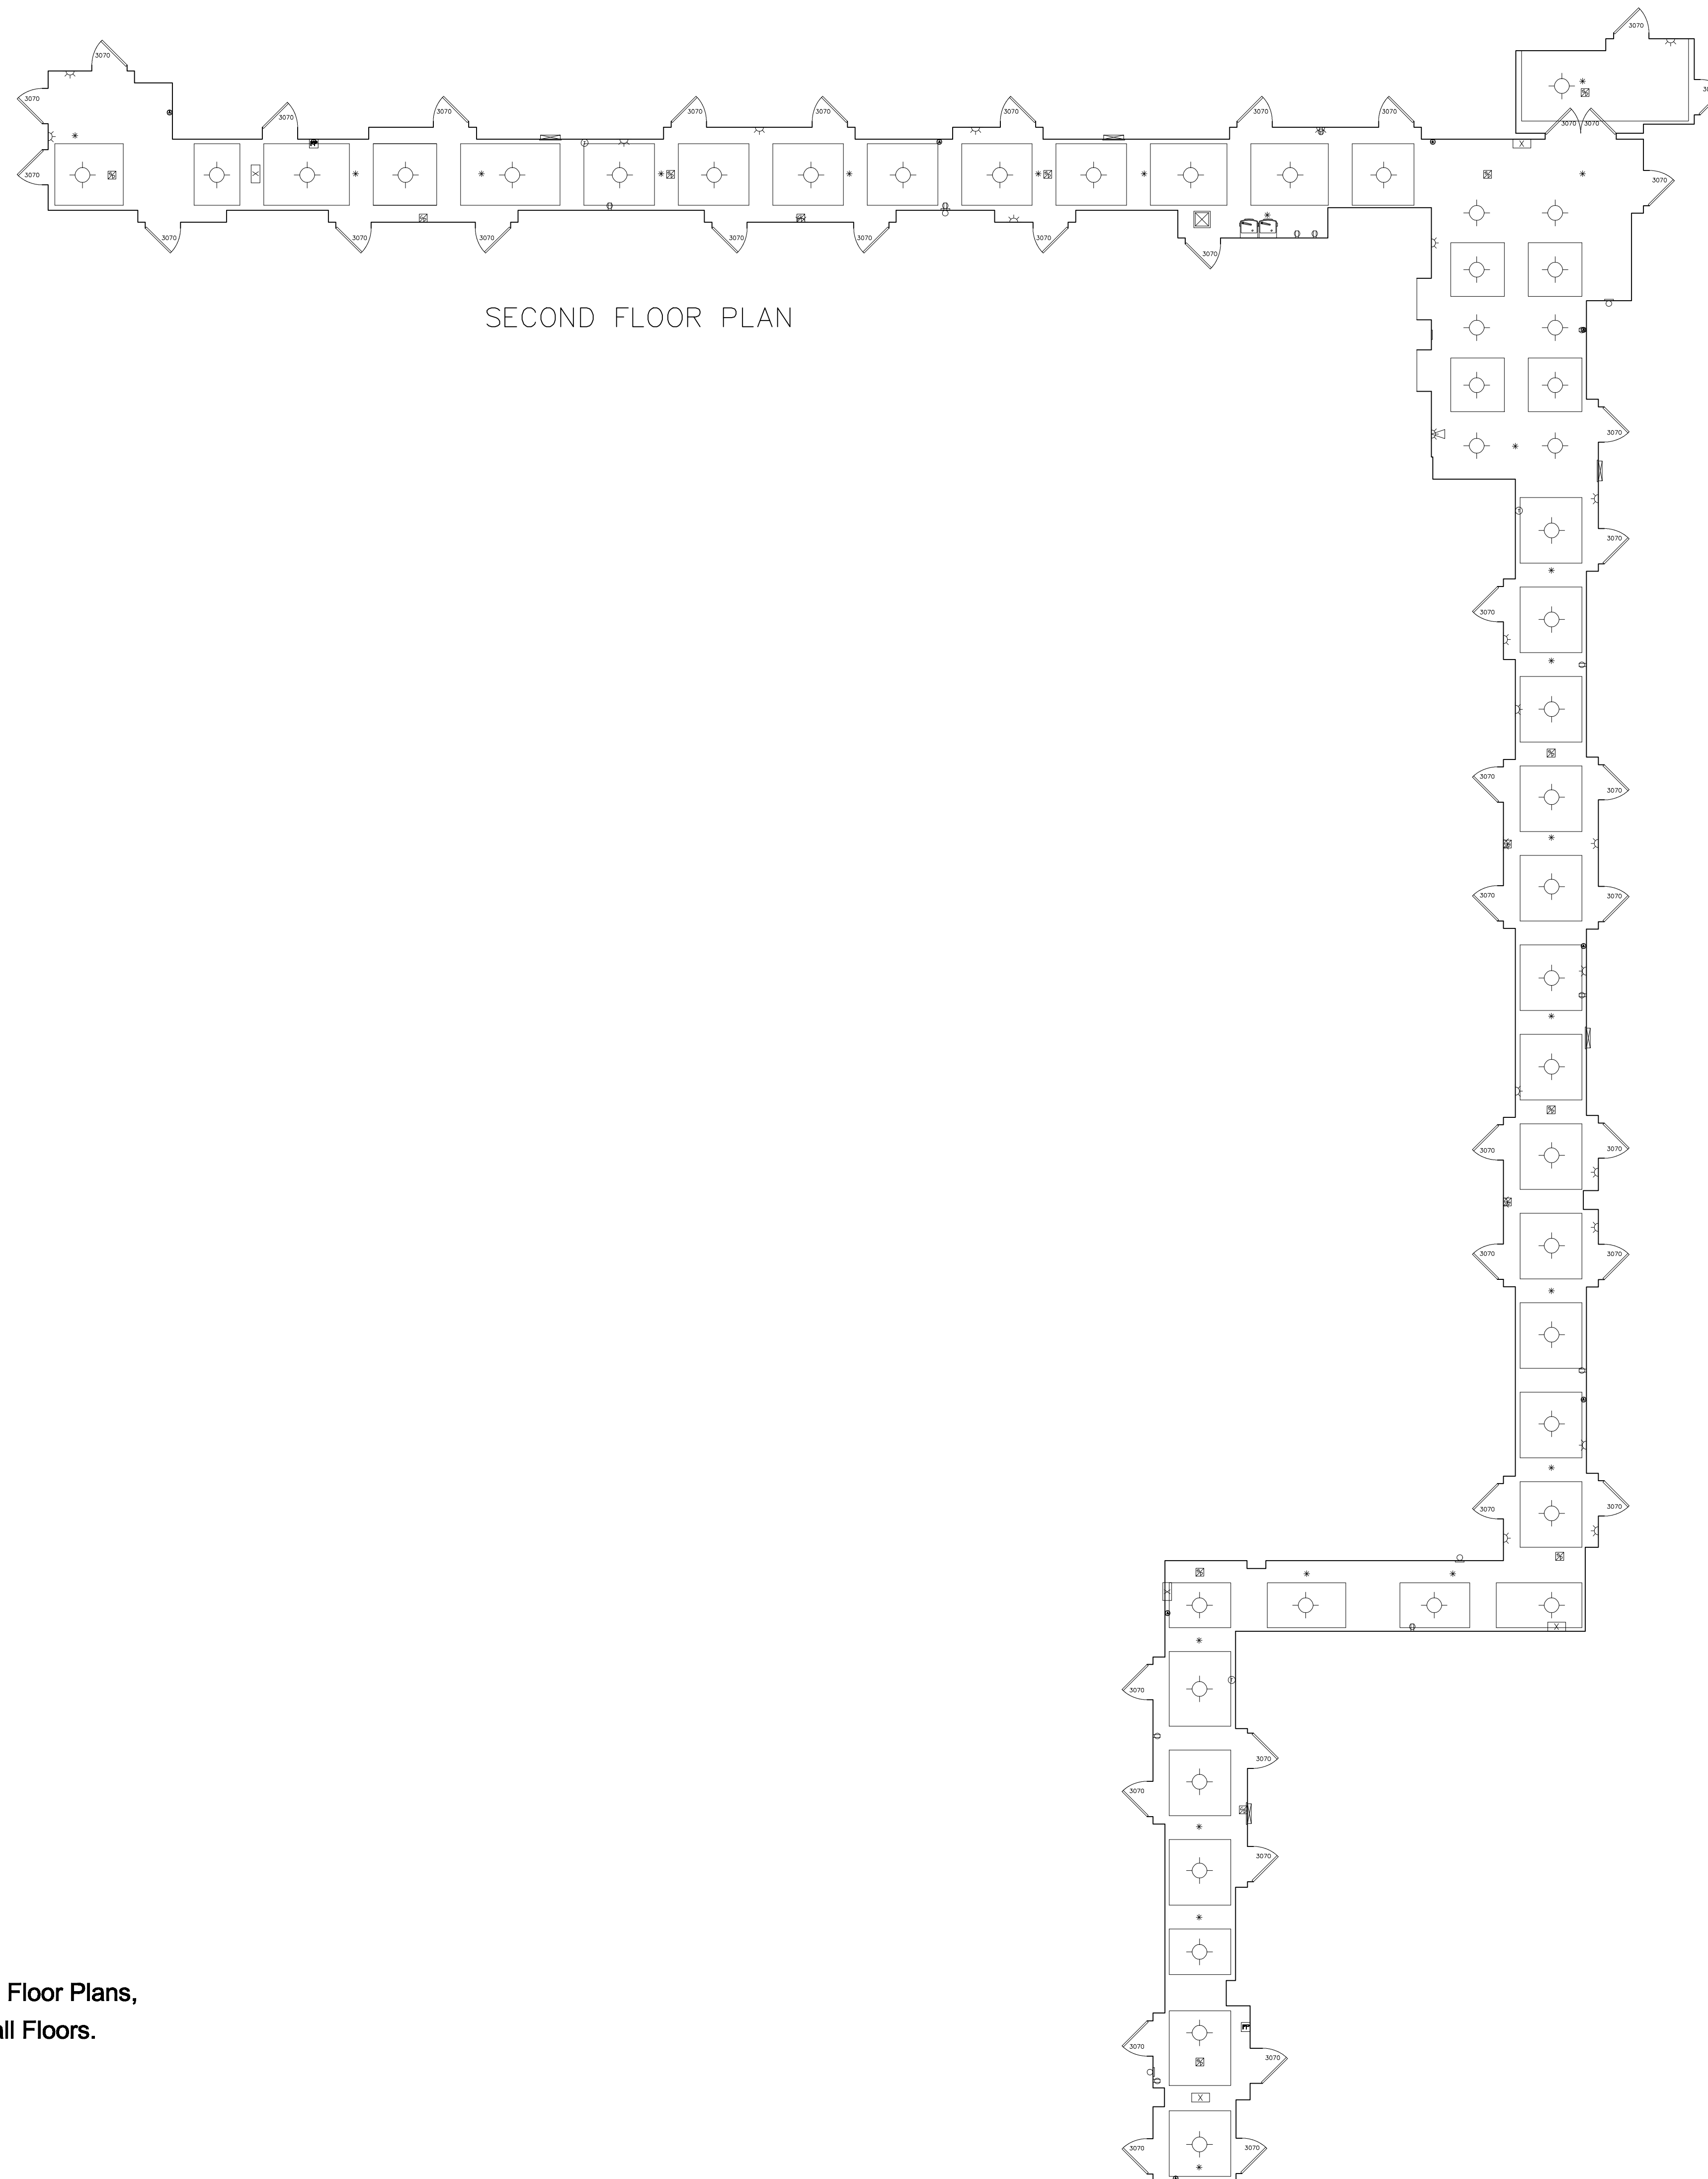


****Scope of work Checklist includes: Floor Plans, RCP Plans and Electrical Plans on all Floors.**



ARCHITECTURAL AS BUILT
Limelight Hotel
Aspen, CO 81611

01	100% SUBMISSION	11/16/2020
NO.	ISSUES REVISIONS	DATE
		SHEET TITLE
2ND FLOOR PLAN		
HL	PROJECT MANAGER	
HL	PROJECT DIRECTOR	
012317-1	PROJECT NUMBER	
1/8"=1'-0"	SCALE	
BB	DRAWN BY	
	SHEET NUMBER	

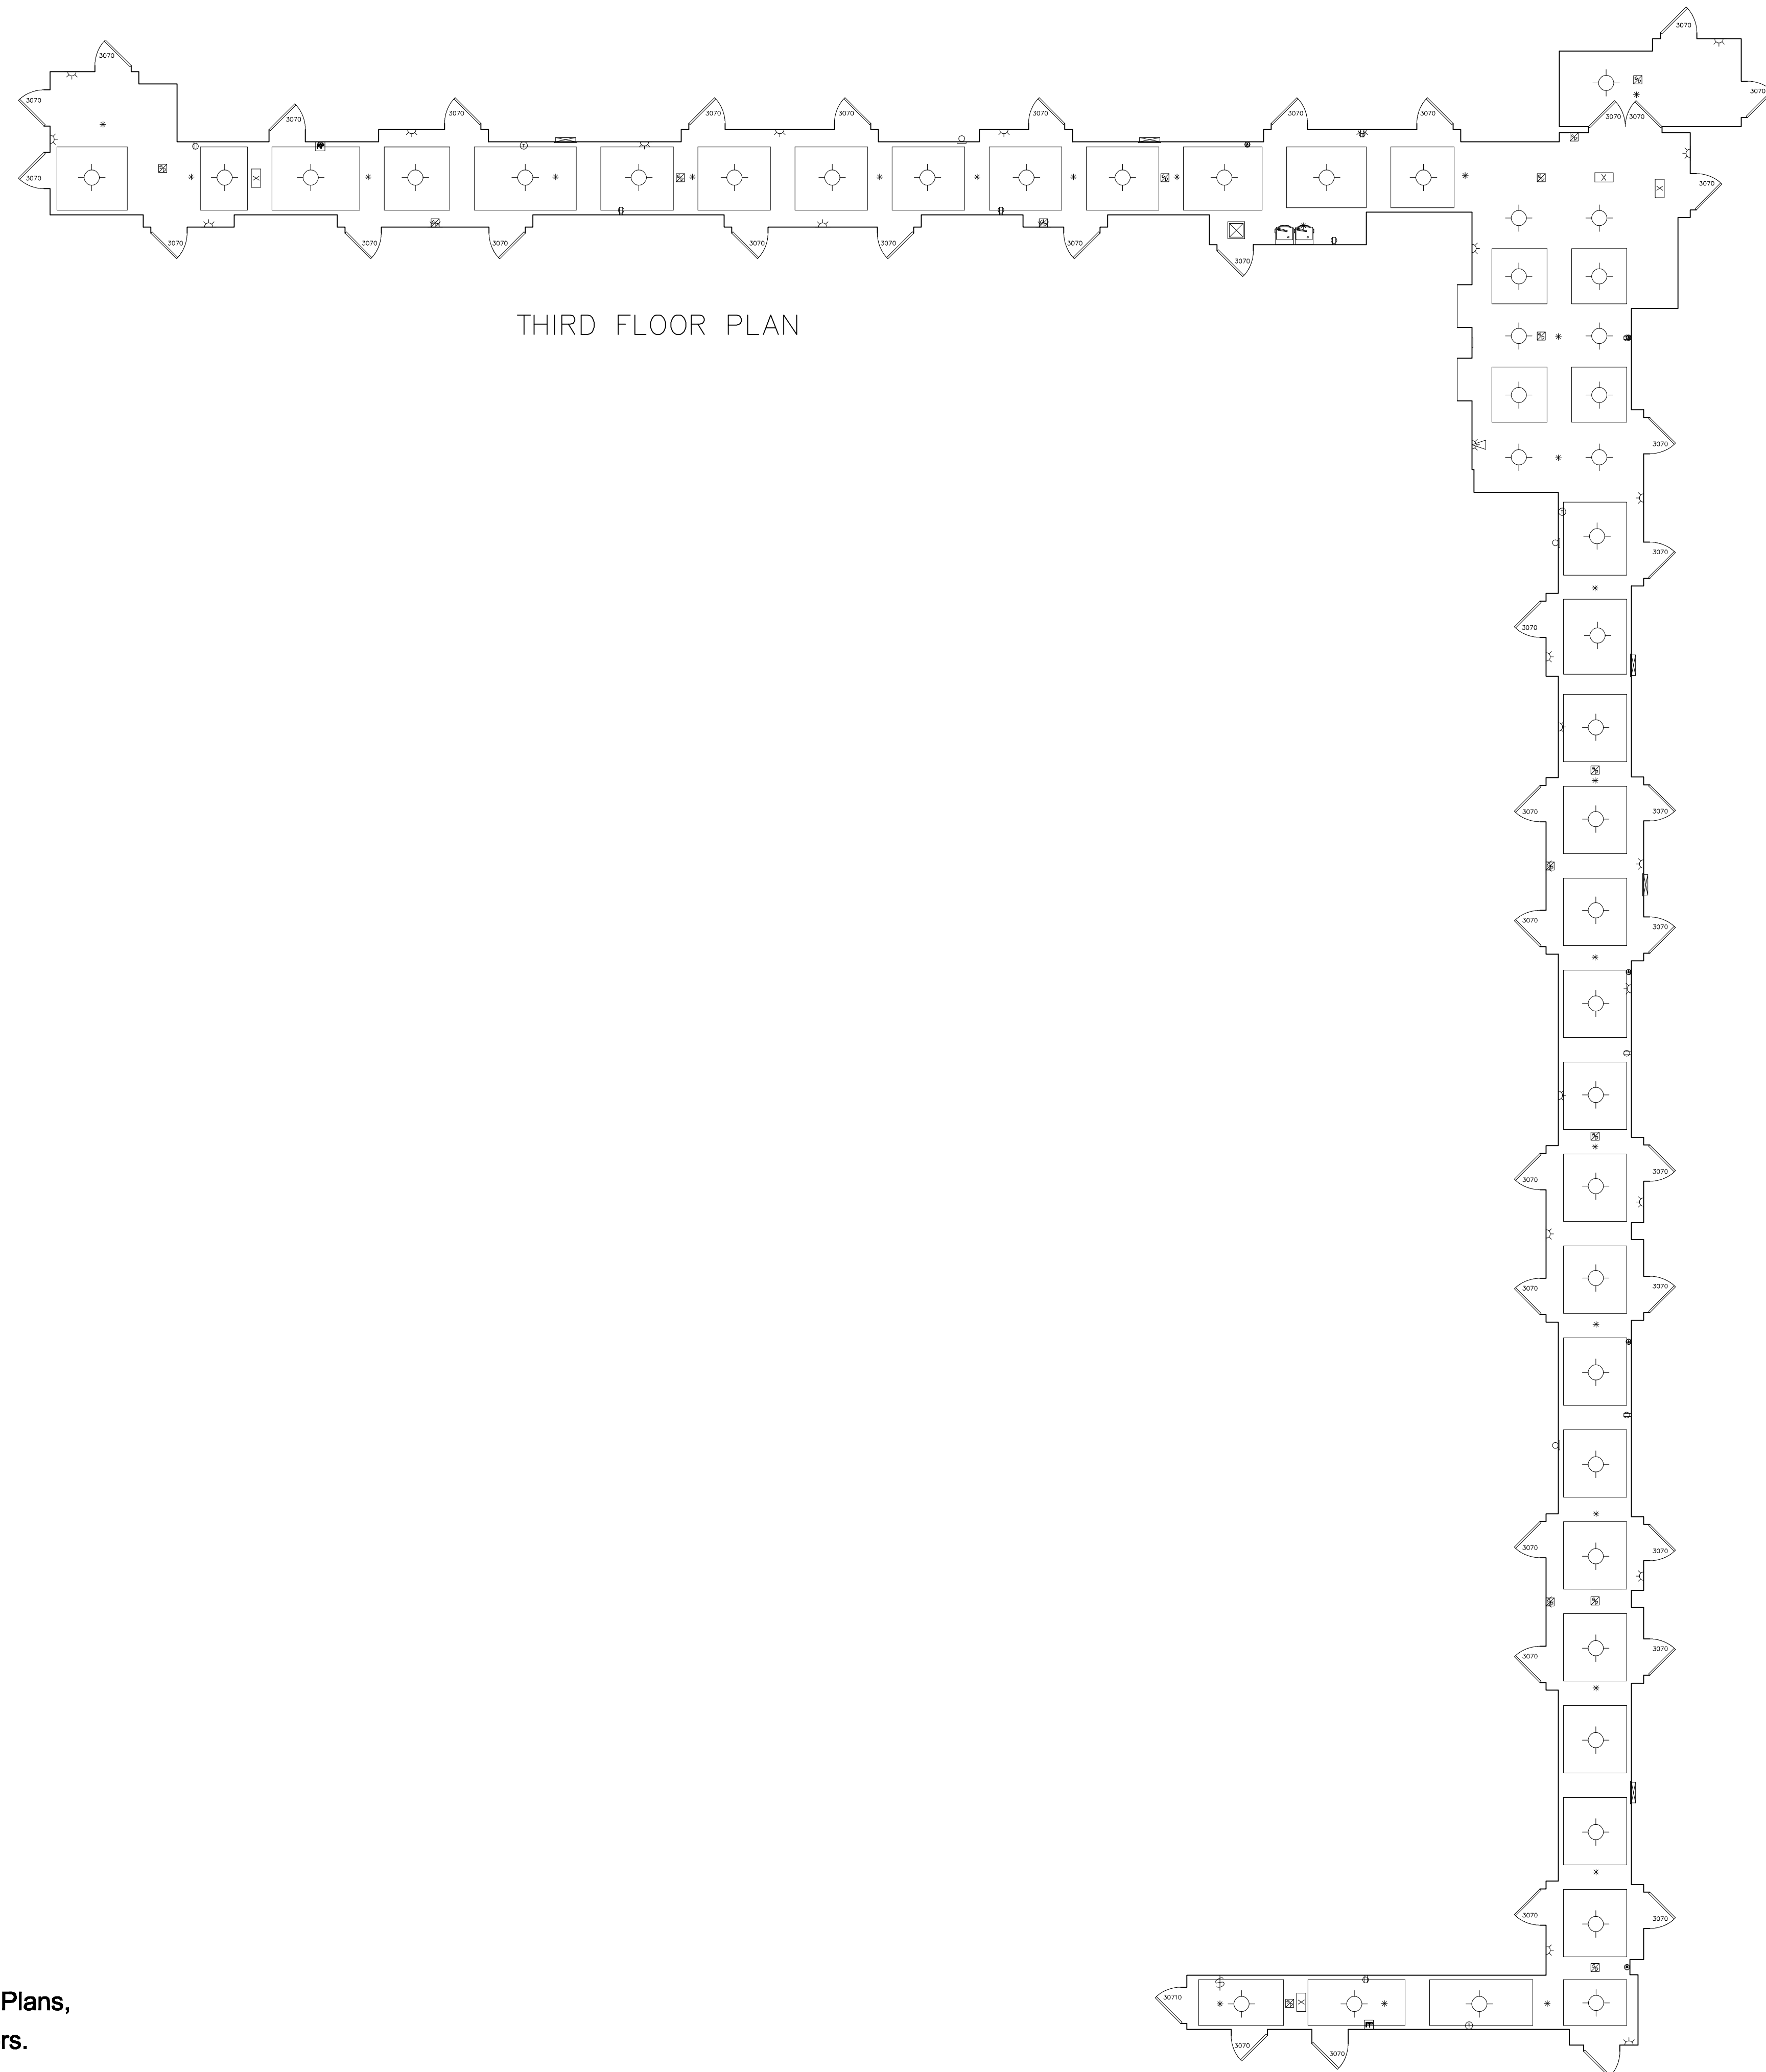

****Scope of work Checklist includes: Floor Plans, RCP Plans and Electrical Plans on all Floors.**

ARCHITECTURAL AS BUILT
Limelight Hotel
Aspen, CO 81611

01	100% SUBMISSION	11/16/2020	
NO.	ISSUES REVISIONS	DATE	
		SHEET TITLE	
3RD FLOOR PLAN			
HL	PROJECT MANAGER		
HL	PROJECT DIRECTOR		
012317-1		PROJECT NUMBER	
1/8"=1'-0"		SCALE	
BB	DRAWN BY		
	SHEET NUMBER		

