


AS-BUILT DOCUMENTATION

Edwards, CO 81632

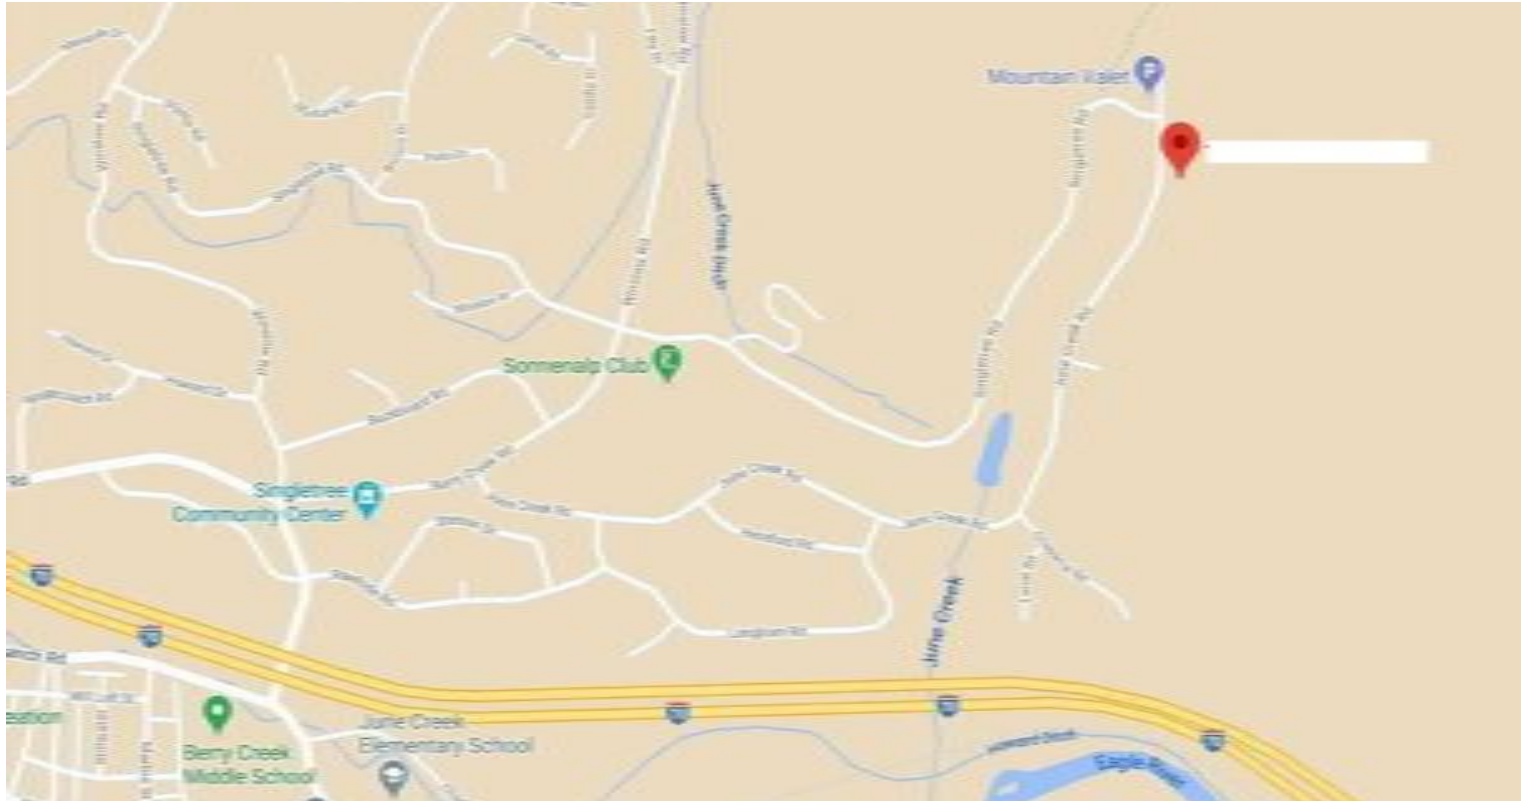

VICINITY MAP
SCALE: NTS

AREA DATA	
BASEMENT	749 SF
GARAGE	653 SF
FIRST FLOOR	1679 SF
SECOND FLOOR	666 SF
Grand total	3740 SF

DRAWING INDEX

- 0C1 COVER
- 0SL SYMBOL LEGEND
- AB-1 BASEMENT PLAN
- AB-2 FIRST FLOOR PLAN
- AB-3 SECOND FLOOR PLAN
- AB-4 BASEMENT REFLECTED CEILING PLAN
- AB-5 FIRST FLOOR REFLECTED CEILING PLAN
- AB-6 SECOND FLOOR REFLECTED CEILING PLAN
- AB-7 EXTERIOR ELEVATIONS
- AB-8 3D VIEWS
- AB-9 3D SECTIONS

As BUILT

PROFESSIONALS

www.asbuiltprofessionals.com

A DIVISION OF:

AEC

CONSULTANTS INC

844.272.8458

844 A S B U I L T

© 2020 AEC CONSULTANTS INC

ARCHITECTURAL AS BUILT
Edwards, CO 81632




 

 



 




 

 










01	100% SUBMISSION	SEE COVER SHEET
NO.	ISSUES / REVISIONS	DATE
SHEET TITLE		
COVER		
PROJECT MANAGER		
PROJECT DIRECTOR		
PROJECT NUMBER		
SCALE		
DRAWN BY		
SHEET NUMBER		

 100% SUBMITTAL








 





0C1

SYMBOLS LEGEND








RCP

EXH		EXHAUST VENT	VL		TRACK LIGHT OR VANITY LIGHT
L1		CEILING MOUNTED LIGHT FIXTURE	WL		WALL-MOUNTED LIGHT FIXTURE
L		CEILING MOUNTED DIRECTIONAL LIGHT	ES		EMERGENCY EXIT SIGN
RC		RECESSED CAN LIGHT	EL		EMERGENCY EXIT LIGHT
EYE		EYEBALL OR SMALL CAN LIGHT	EEL		EMERGENCY EXIT LIGHT W/ SIGN
HPL		PENDANT LIGHT	STAIR		LIGHTED STAIR SIGN
FL		INDIVIDUAL FLUOR. LAY-IN FIXTURE 4 BULB	F		FLOOD LIGHT
FL2		INDIVIDUAL FLUOR. HANGING FIXTURE 2 BULB	PC		PHOTO CELL
FL3		INDIVIDUAL FLUOR. FLUSH MOUNT FIXTURE 4 BULB	F1		CEILING FAN
C		CAMERA	FILK		CEILING FAN W/ LIGHT KIT
M		MOTION DET.			
SUP		SUPPLY VENT			
SUP2		SUPPLY VENT			
RET		RETURN VENT			
RET2		RETURN VENT			
spe		SPEAKER	J		JUNCTION BOX

 ELECTRIC

DATA		DATA OUTLET
TEL		TELEPHONE JACK
S1		ELECTRIC SWITCH
TV		CABLE TELEVISION OUTLET
P1		DUPLEX RECEPTACLE OUTLET
P3		SPECIAL PURPOSE CONNECTION OR OUTLET
PQ		QUADRUPLEX RECEPTACLE OUTLET
PF		FLOOR DUPLEX RECEPTACLE OUTLET
PNL		ELECTRIC PANEL
MTR		ELECTRIC METER
BUT		BUTTON SWITCH
DISC		DISCONNECT SWITCH
LG		GROUND/FLOOR LIGHT
KP		KEY PAD

FIRE PROTECTION

FE		FIRE EXTINGUISHER
FP		FIRE PULL
AS		FIRE ALARM (HORN/STRTOBE)
SD		SMOKE DETECTOR
SS		SMOKE ALARM SPEAKER
SP		SPRINKLER HEAD CEILING MOUNT
SPW		SPRINKLER HEAD WALL MOUNT

MEP

TH		THERMOSTAT
FD	 	FLOOR DRAIN
V		VALVE
HB		HOSE BIB
WS		WATER SUPPLY
HEAT		SUSPENDED GAS HEATER

MISC

BOLLARD		BOLLARD
ELEVATION SYMBOL	11-4-11/16	SPOT ELEVATION

PHOTO DOCUMENTATION LEGEND

INDICATES LOCATION OF CAMERA

INDICATES DIRECTION OF CAMERA LENS
AND CORRESPONDING PHOTO / VIDEO
NUMBER

001

PS (SMALL)
PL (LARGE)

TYPES OF DOCUMENTATION

360

000

V-000


GROUND BASED
PHOTO

GROUND BASED
VIDEO


360° SPHERICAL
PHOTO

AERIAL BASED
PHOTO

AERIAL BASED
VIDEO

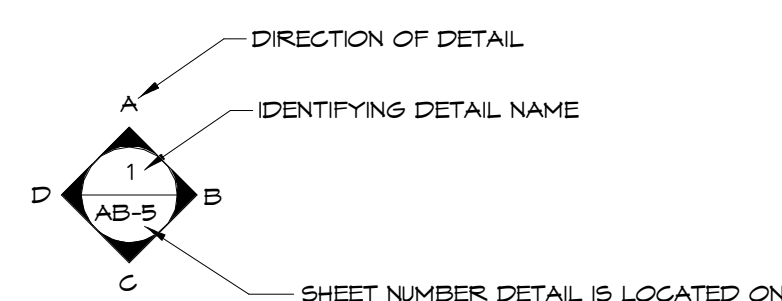

INTERIOR ELEVATIONS

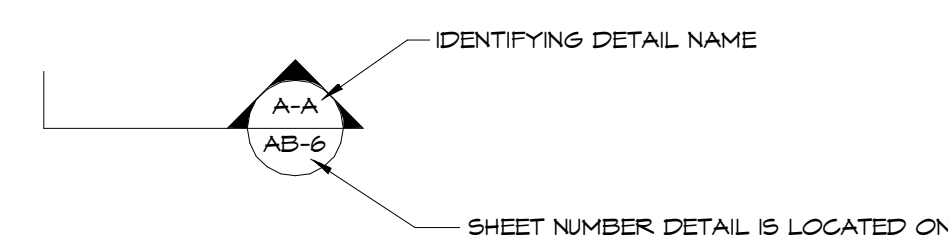

BUILDING SECTION

SYMBOL LEGEND

Designer	PROJECT MANAGER
Designer	PROJECT DIRECTOR
12317-1	PROJECT NUMBER
	SCALE
Author	DRAWN BY
	CHECK NUMBER

OSL

ARCHITECTURAL AS BUILT



Edwards, CO 81632

01	100% SUBMISSION	SEE COVER SHEET
NO.	ISSUES / REVISIONS	DATE

BASEMENT PLAN

Designer	PROJECT MANAGER
Designer	PROJECT DIRECTOR
12317-1	PROJECT NUMBER
	SCALE
Author	DRAWN BY
	SHEET NUMBER

 AB-1

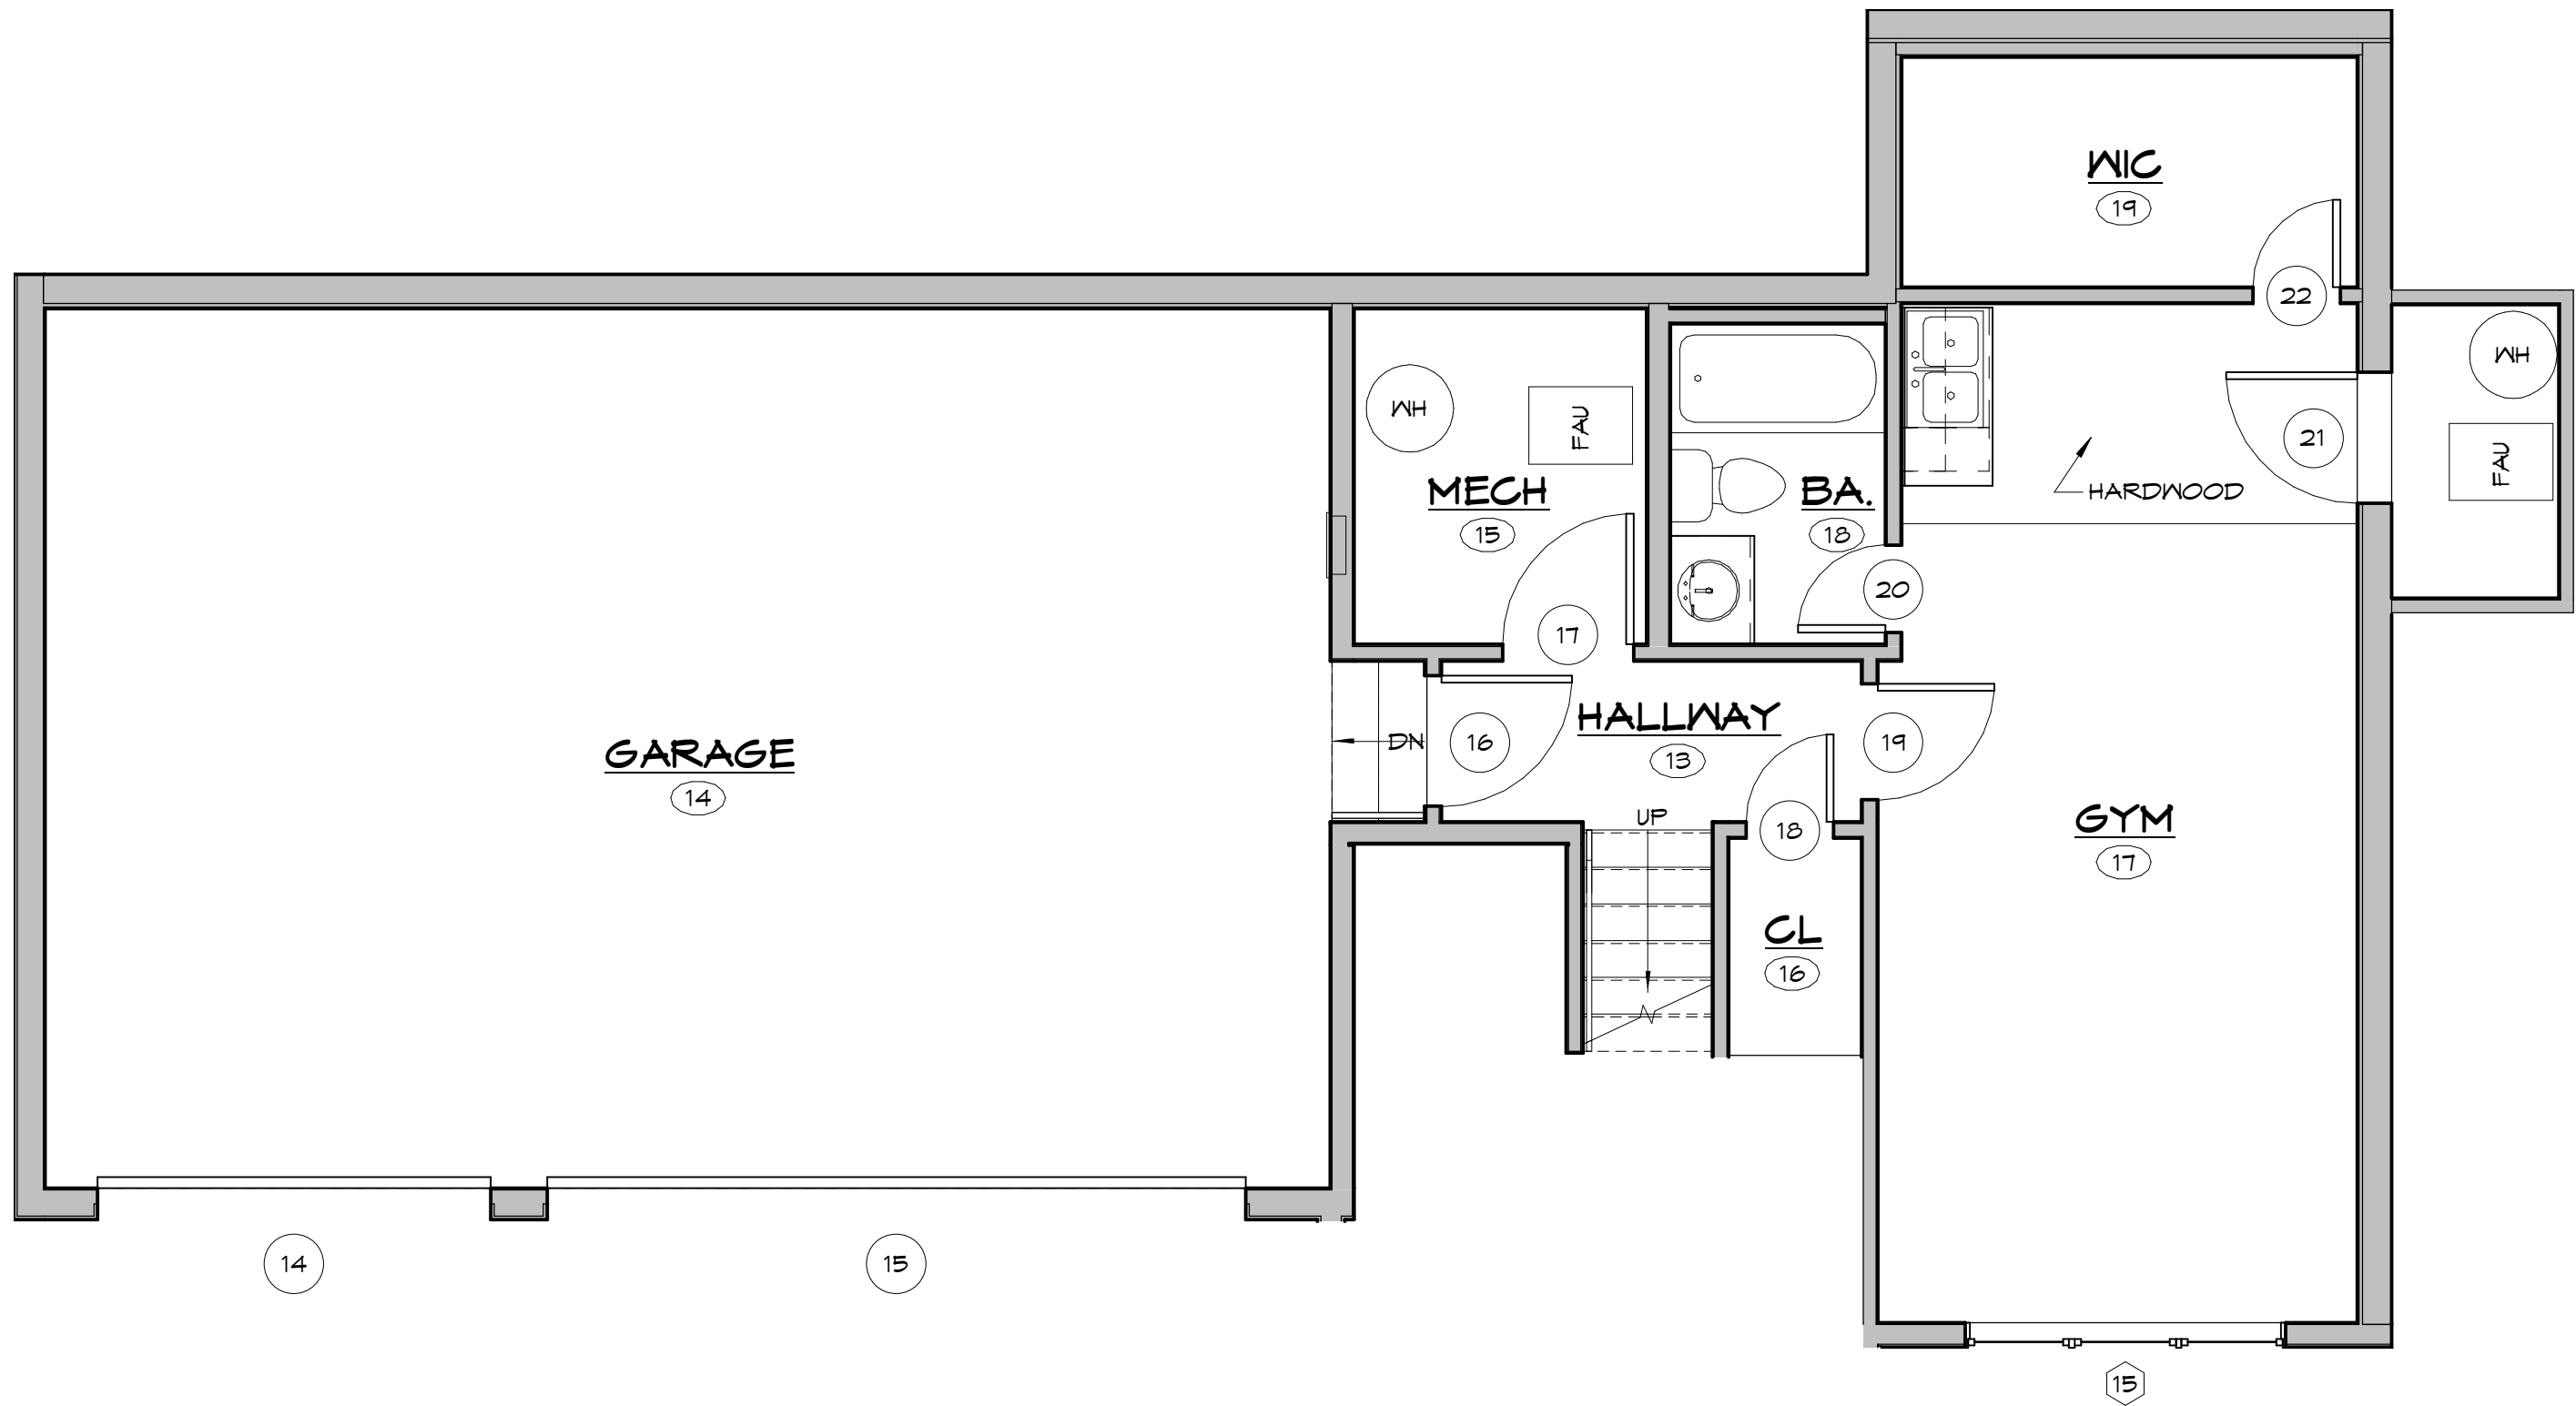

ARCHITECTURAL AS BUILT



Edwards, CO 81632

01	100% SUBMISSION	SEE COVER SHEET
NO.	ISSUES / REVISIONS	DATE

SECOND FLOOR PLAN

Designer	PROJECT MANAGER
Designer	PROJECT DIRECTOR
12317-1	PROJECT NUMBER
	SCALE
Author	DRAWN BY
	SHEET NUMBER

 AB-3

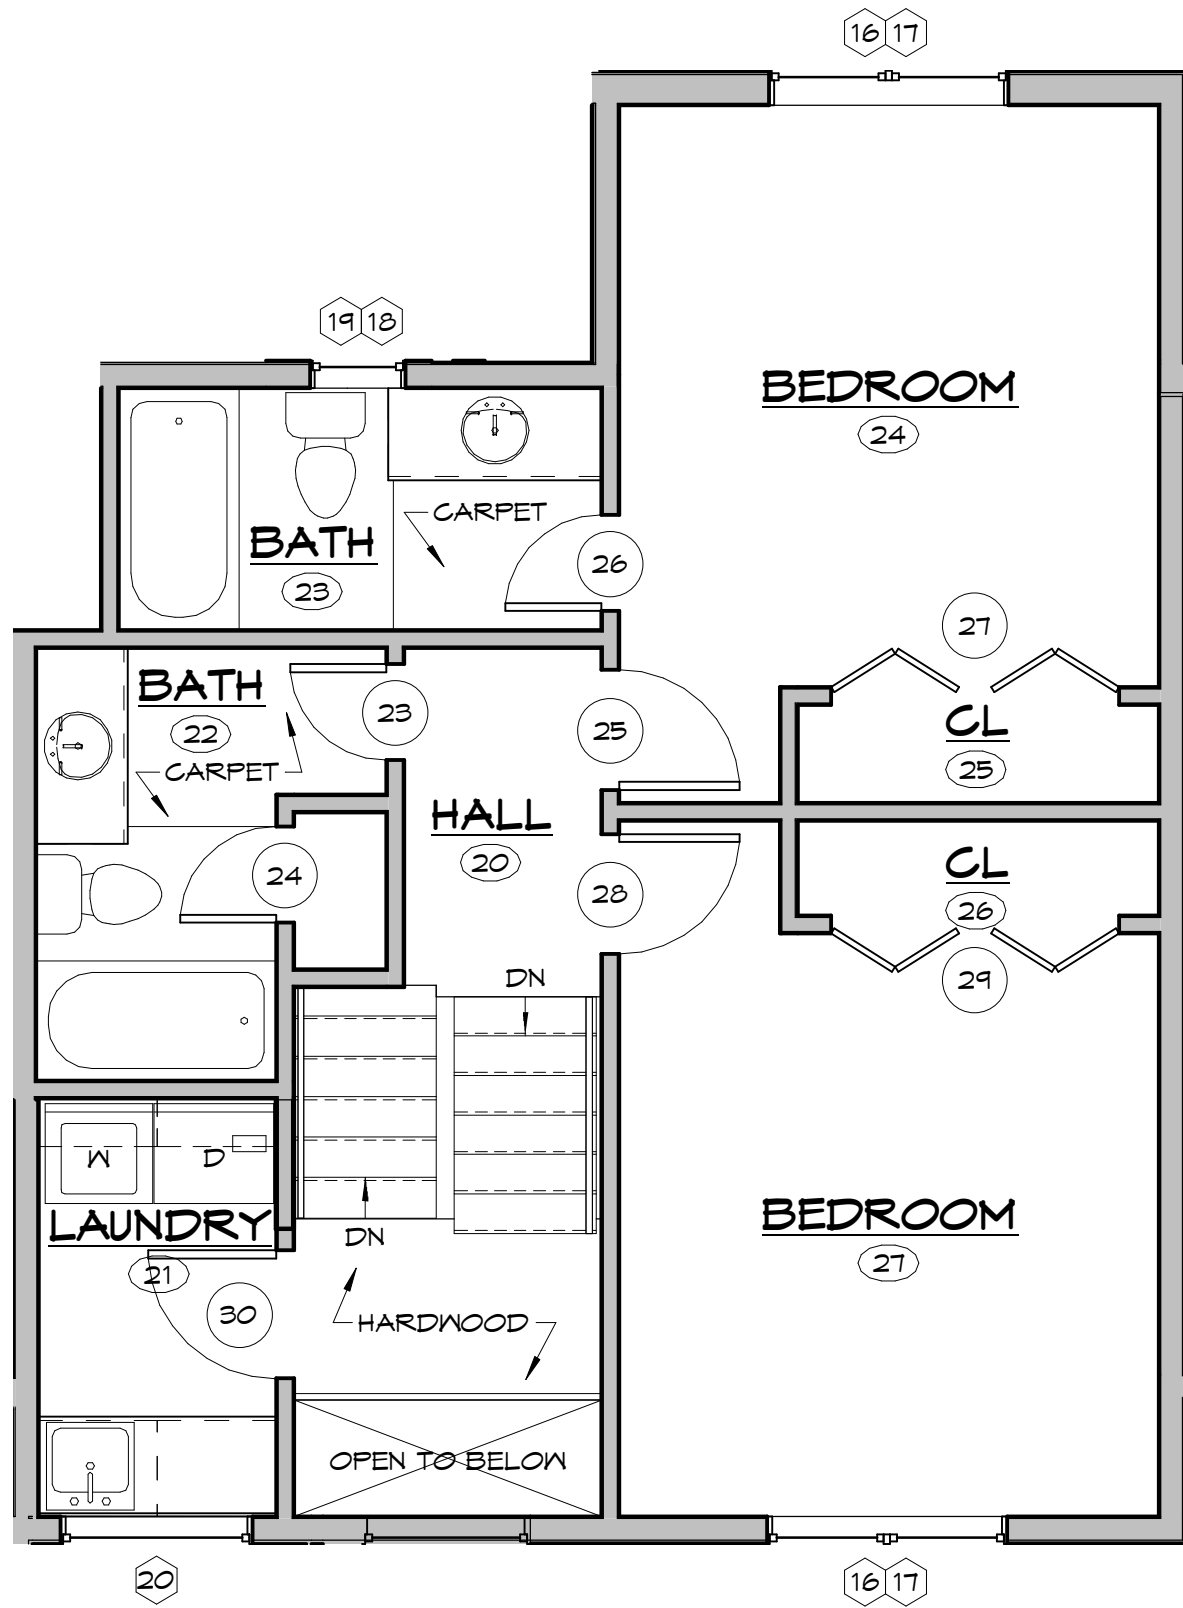





ARCHITECTURAL AS BUILT
Edwards, CO 81632



Designer	PROJECT MANAGER
Designer	PROJECT DIRECTOR
12317-1	PROJECT NUMBER
	SCALE
Author	DRAWN BY
	DATE OF DRAWING

 AB-4

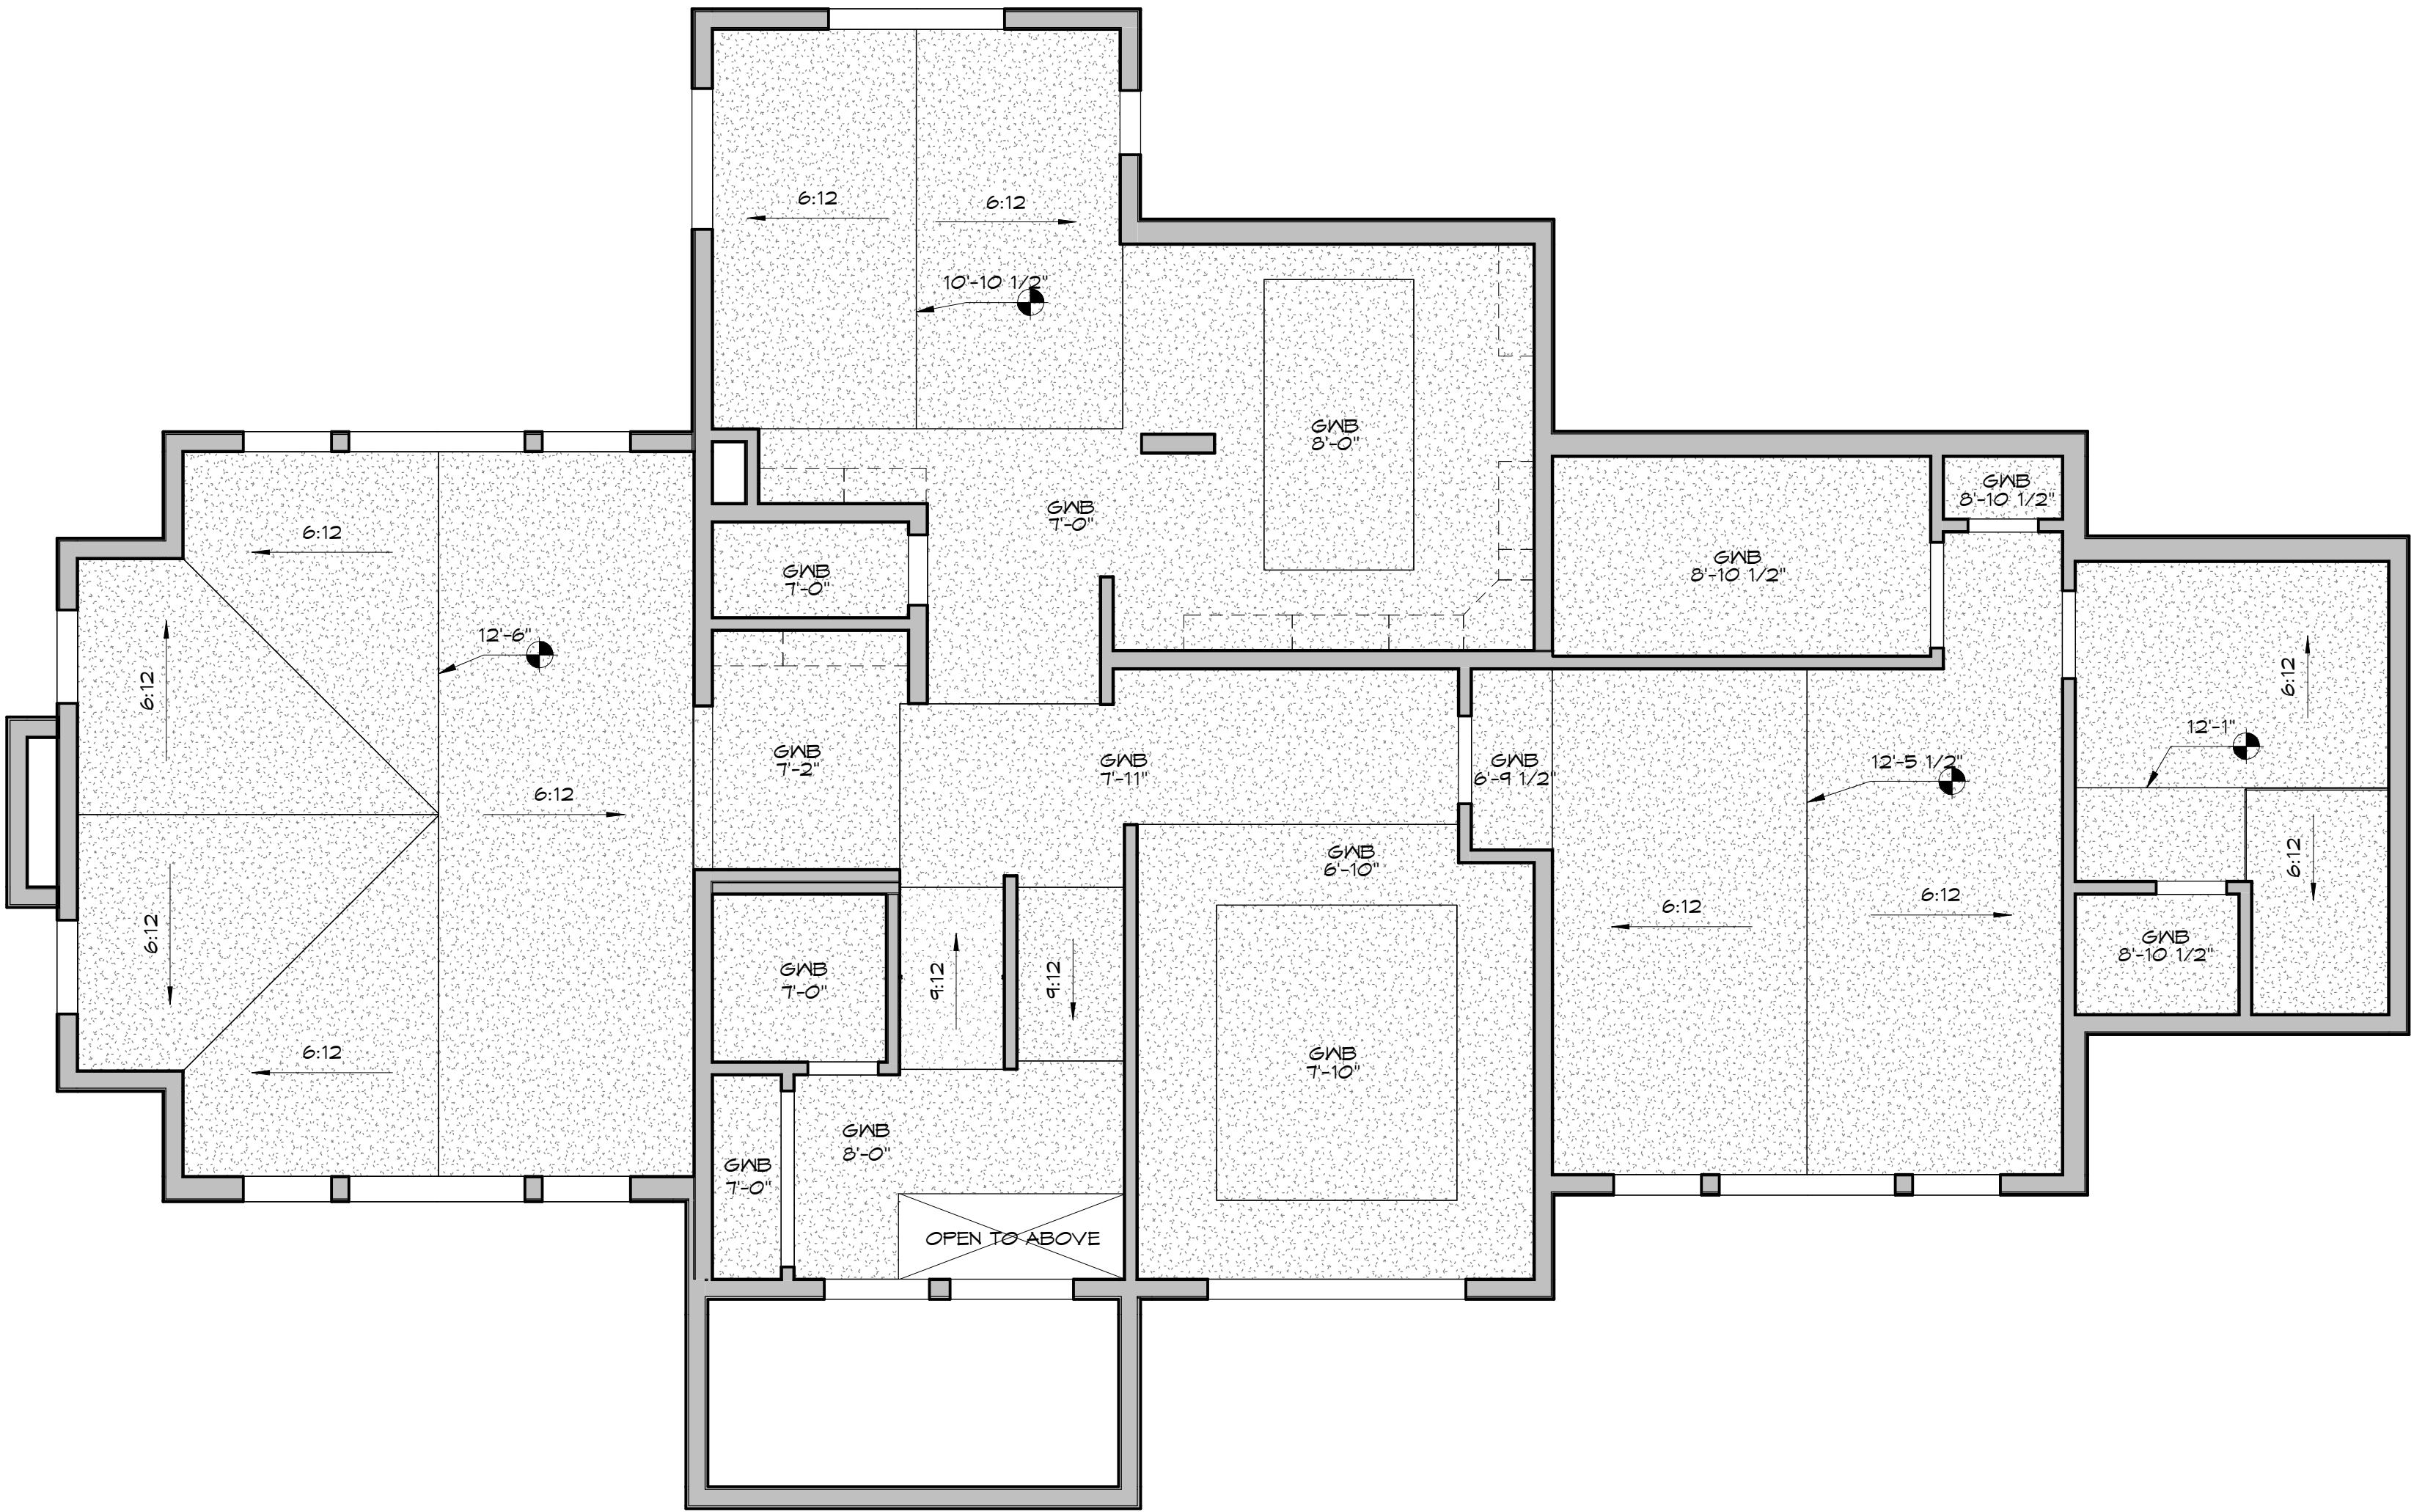

ARCHITECTURAL AS BUILT

Edwards, CO 81632



01	100% SUBMISSION	SEE COVER SHEET
NO.	ISSUES / REVISIONS	DATE
SHEET TITLE		
FIRST FLOOR REFLECTED CEILING PLAN		
Designer	PROJECT MANAGER	
Designer	PROJECT DIRECTOR	
12317-1	PROJECT NUMBER	
	SCALE	
Author	DRAWN BY	
	SHEET NUMBER	

ARCHITECTURAL AS BUILT

Edwards, CO 81632


01	100% SUBMISSION	SEE COVER SHEET
NO.	ISSUES / REVISIONS	DATE
SHEET TITLE		
SECOND FLOOR REFLECTED CEILING PLAN		
Designer	PROJECT MANAGER	
Designer	PROJECT DIRECTOR	
12317-1	PROJECT NUMBER	
	SCALE	
Author	DRAWN BY	
	SHEET NUMBER	

 AB-6

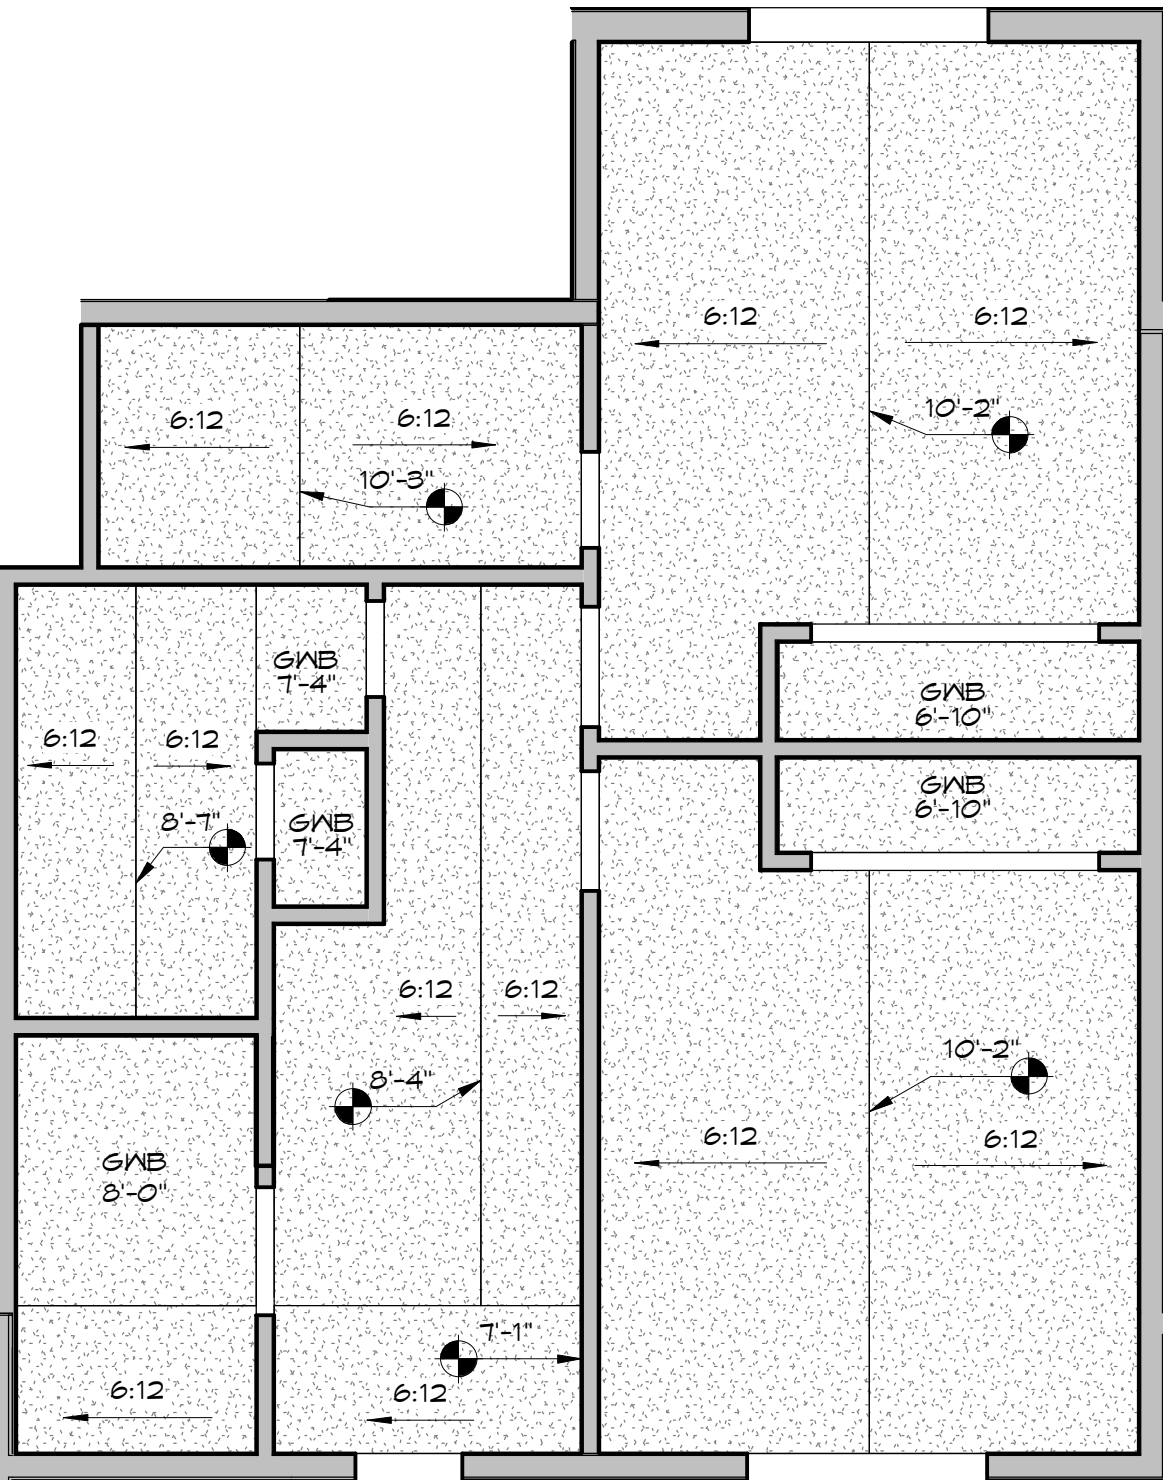





3 West
SCALE: 3/16" = 1'-0"

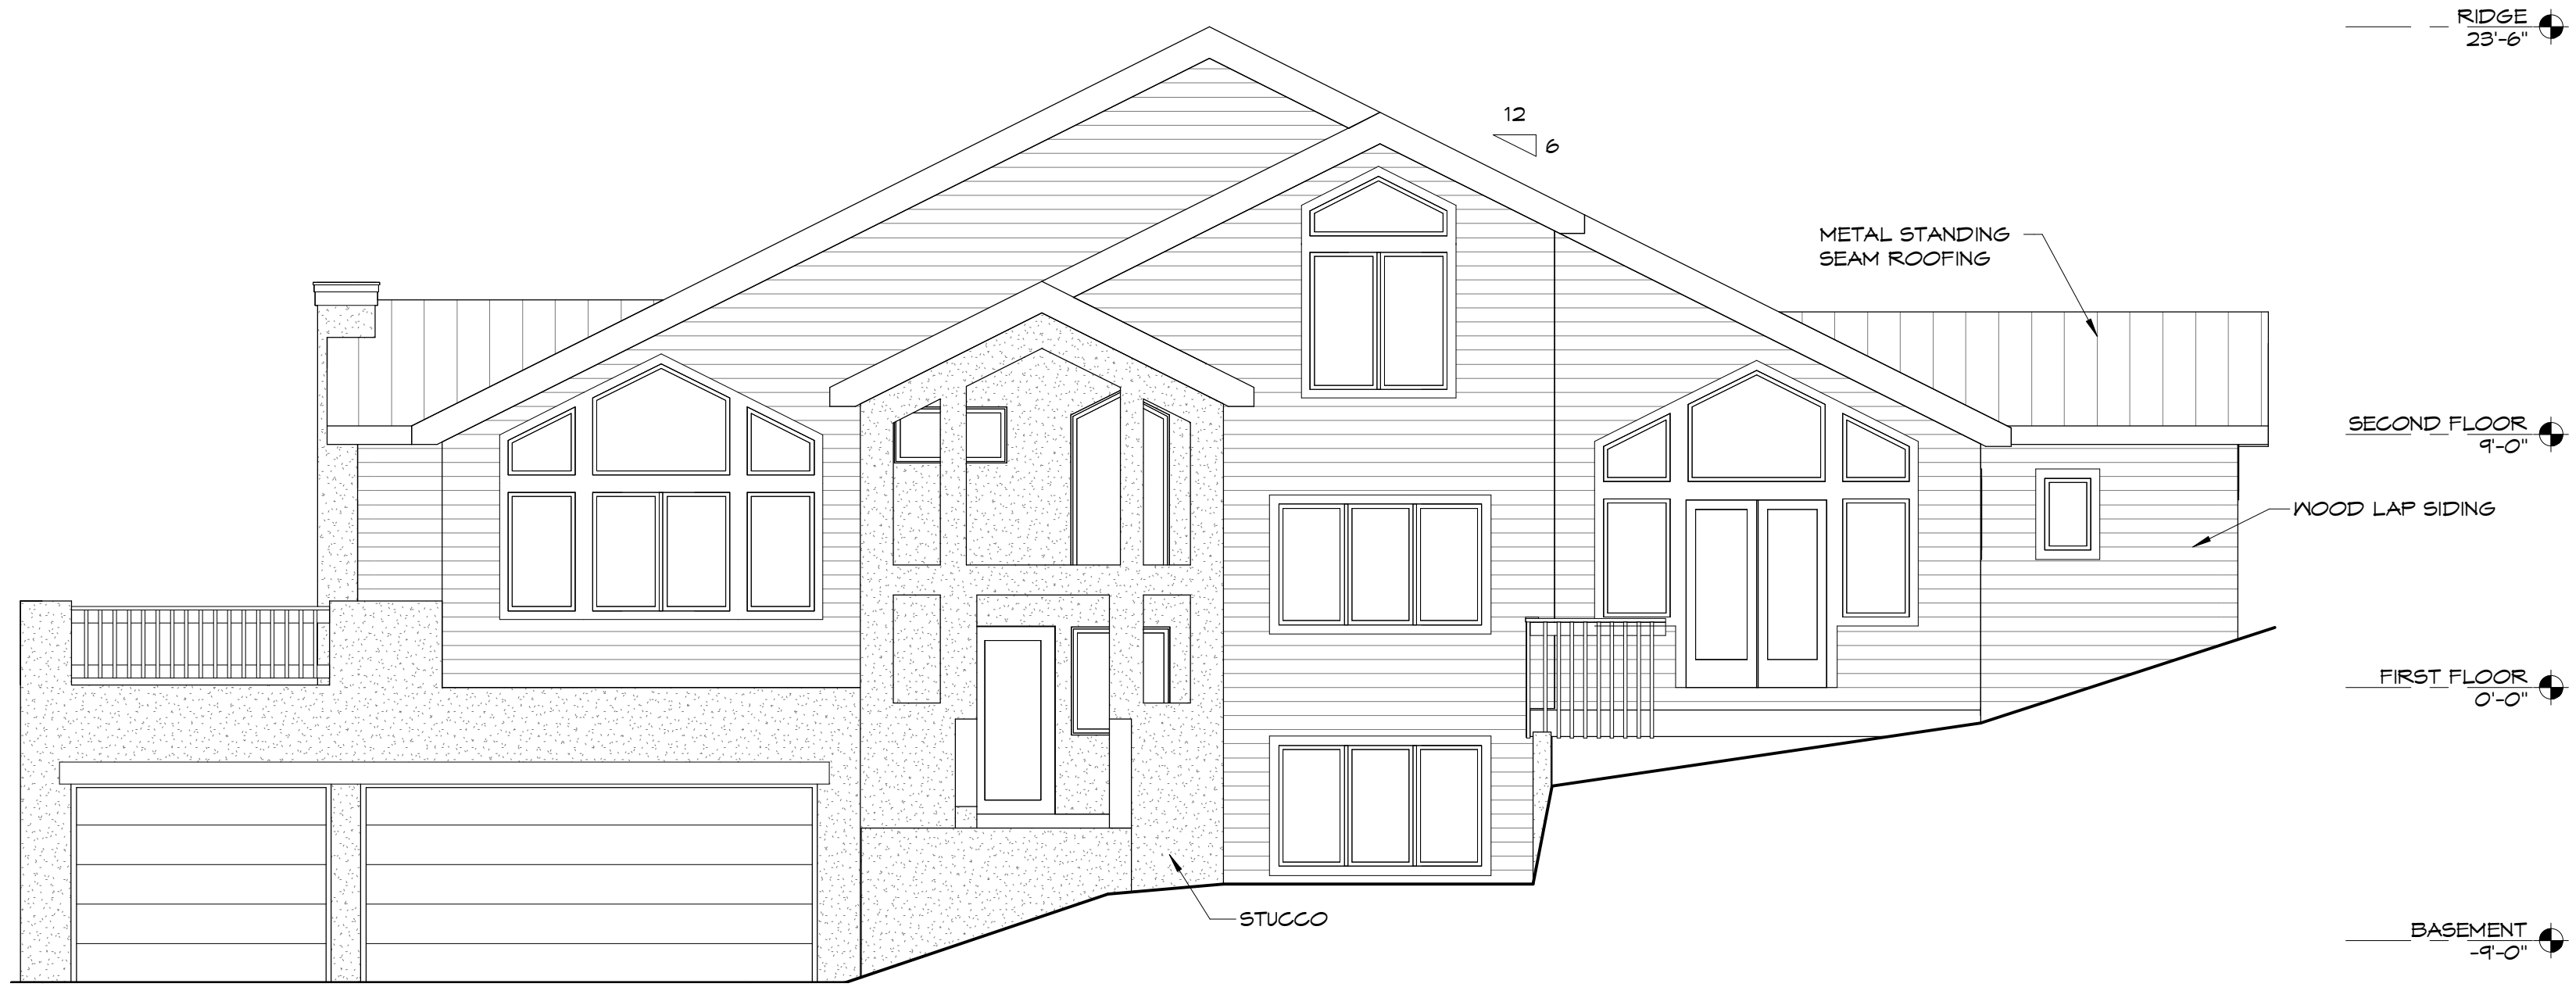

1 South
SCALE: 3/16" = 1'-0"

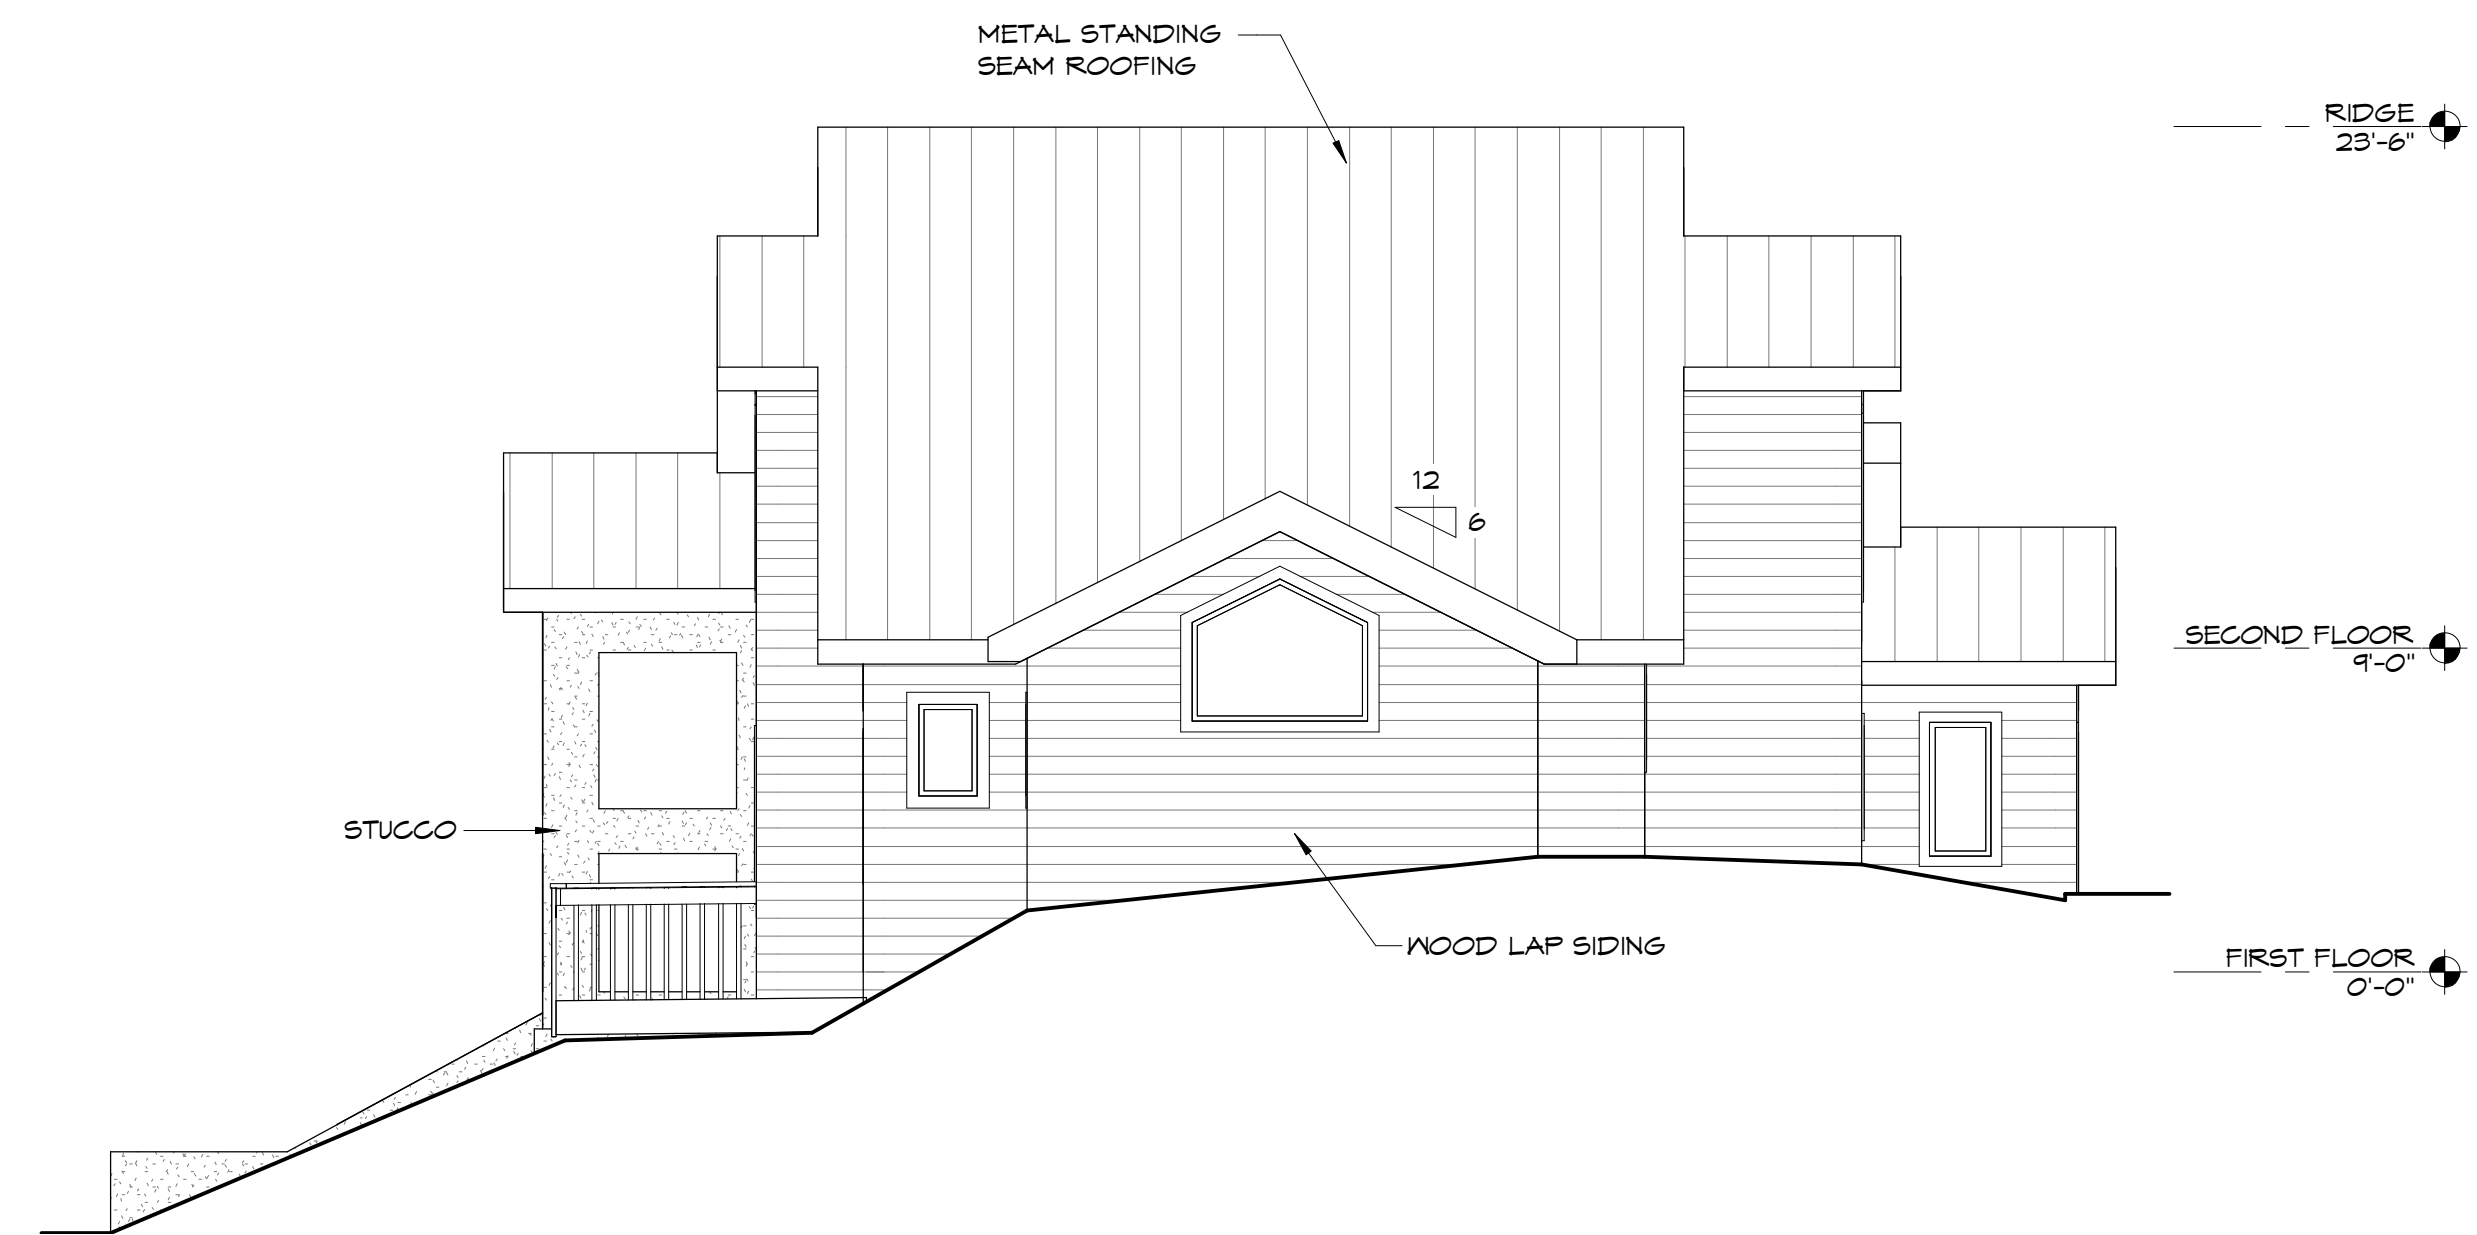

4 East
SCALE: 3/16" = 1'-0"

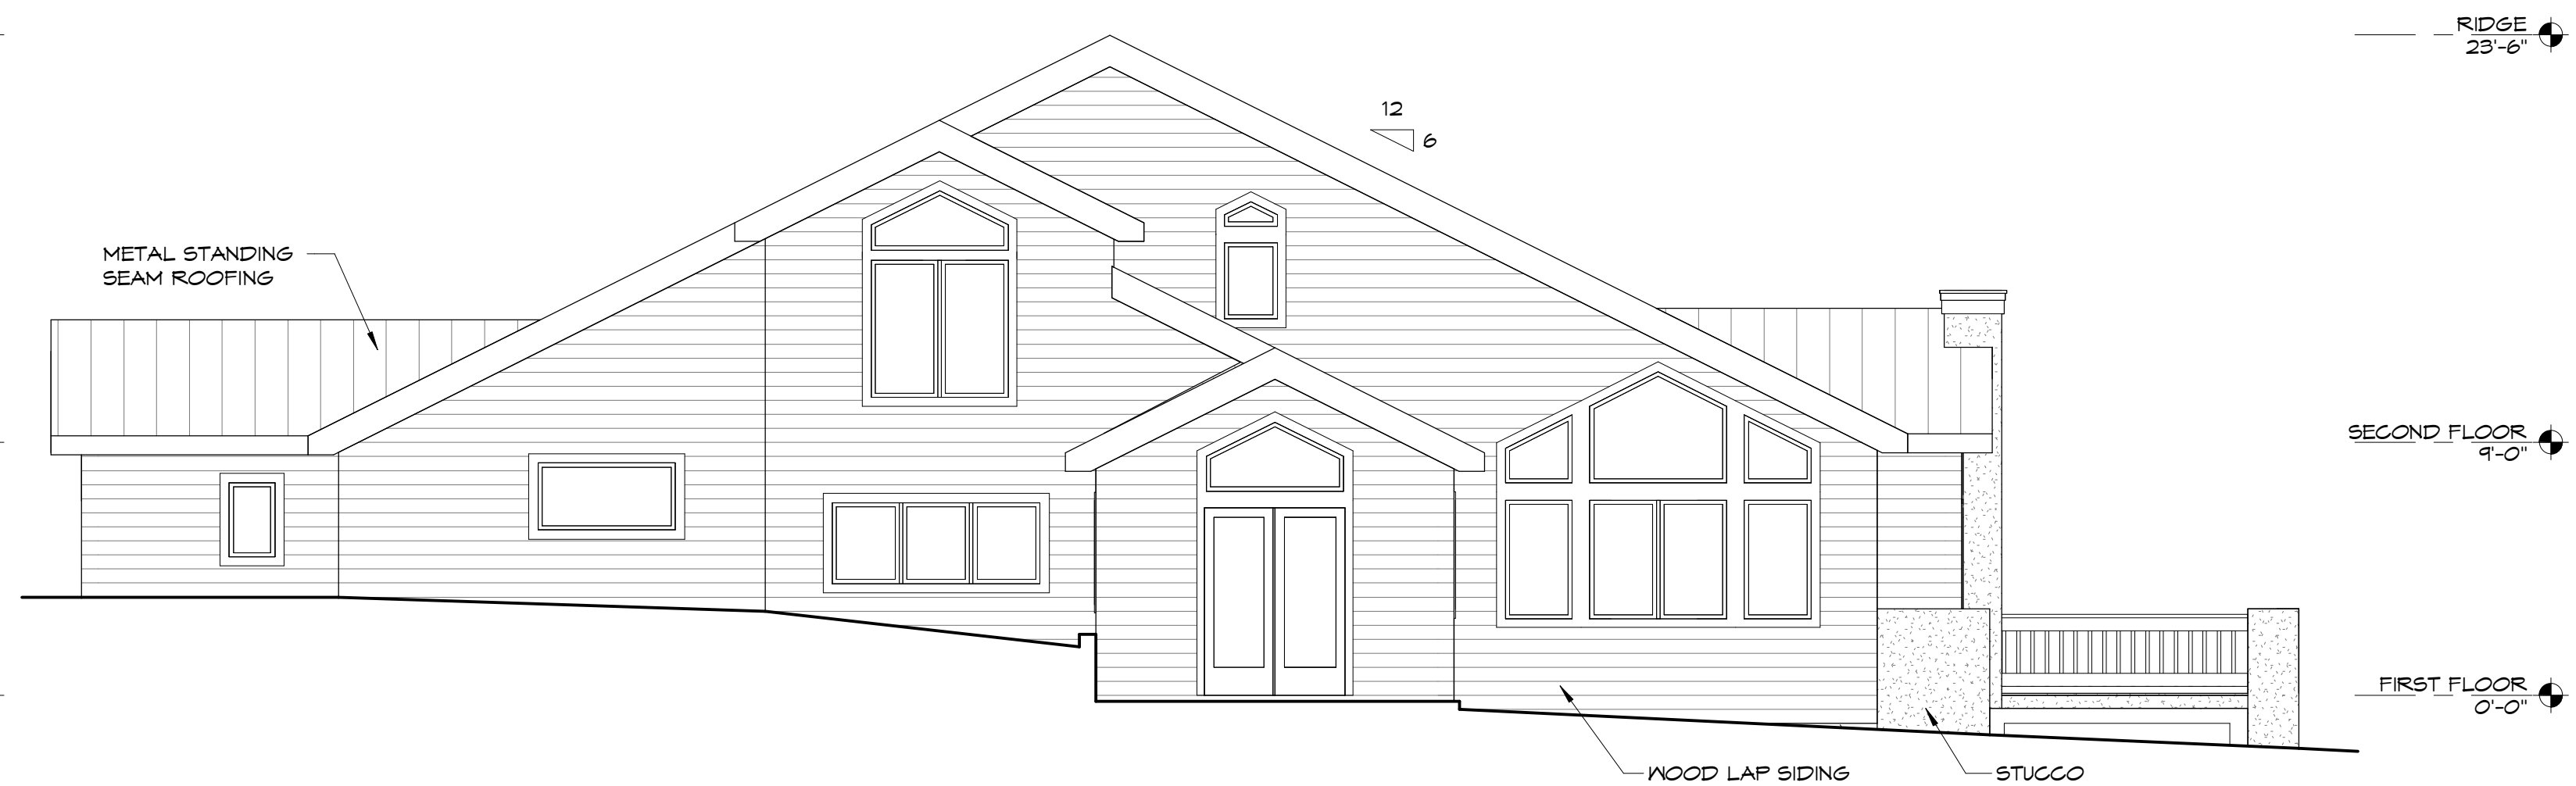

2 North
SCALE: 3/16" = 1'-0"

As BUILT

PROFESSIONALS

www.asbuiltprofessionals.com

A DIVISION OF:

AEC

CONSULTANTS INC

844.272.8458

844 A S B U I L T

© 2020 AEC CONSULTANTS INC


ARCHITECTURAL AS BUILT

Edwards, CO 81632


01	100% SUBMISSION	SEE COVER SHEET
NO.	ISSUES / REVISIONS	DATE
		SHEET TITLE
EXTERIOR ELEVATIONS		
Designer	PROJECT MANAGER	
Designer	PROJECT DIRECTOR	
12317-1	PROJECT NUMBER	
	SCALE	
	DRAWN BY	
Author	SHEET NUMBER	
AB-7		



SECOND FLOOR

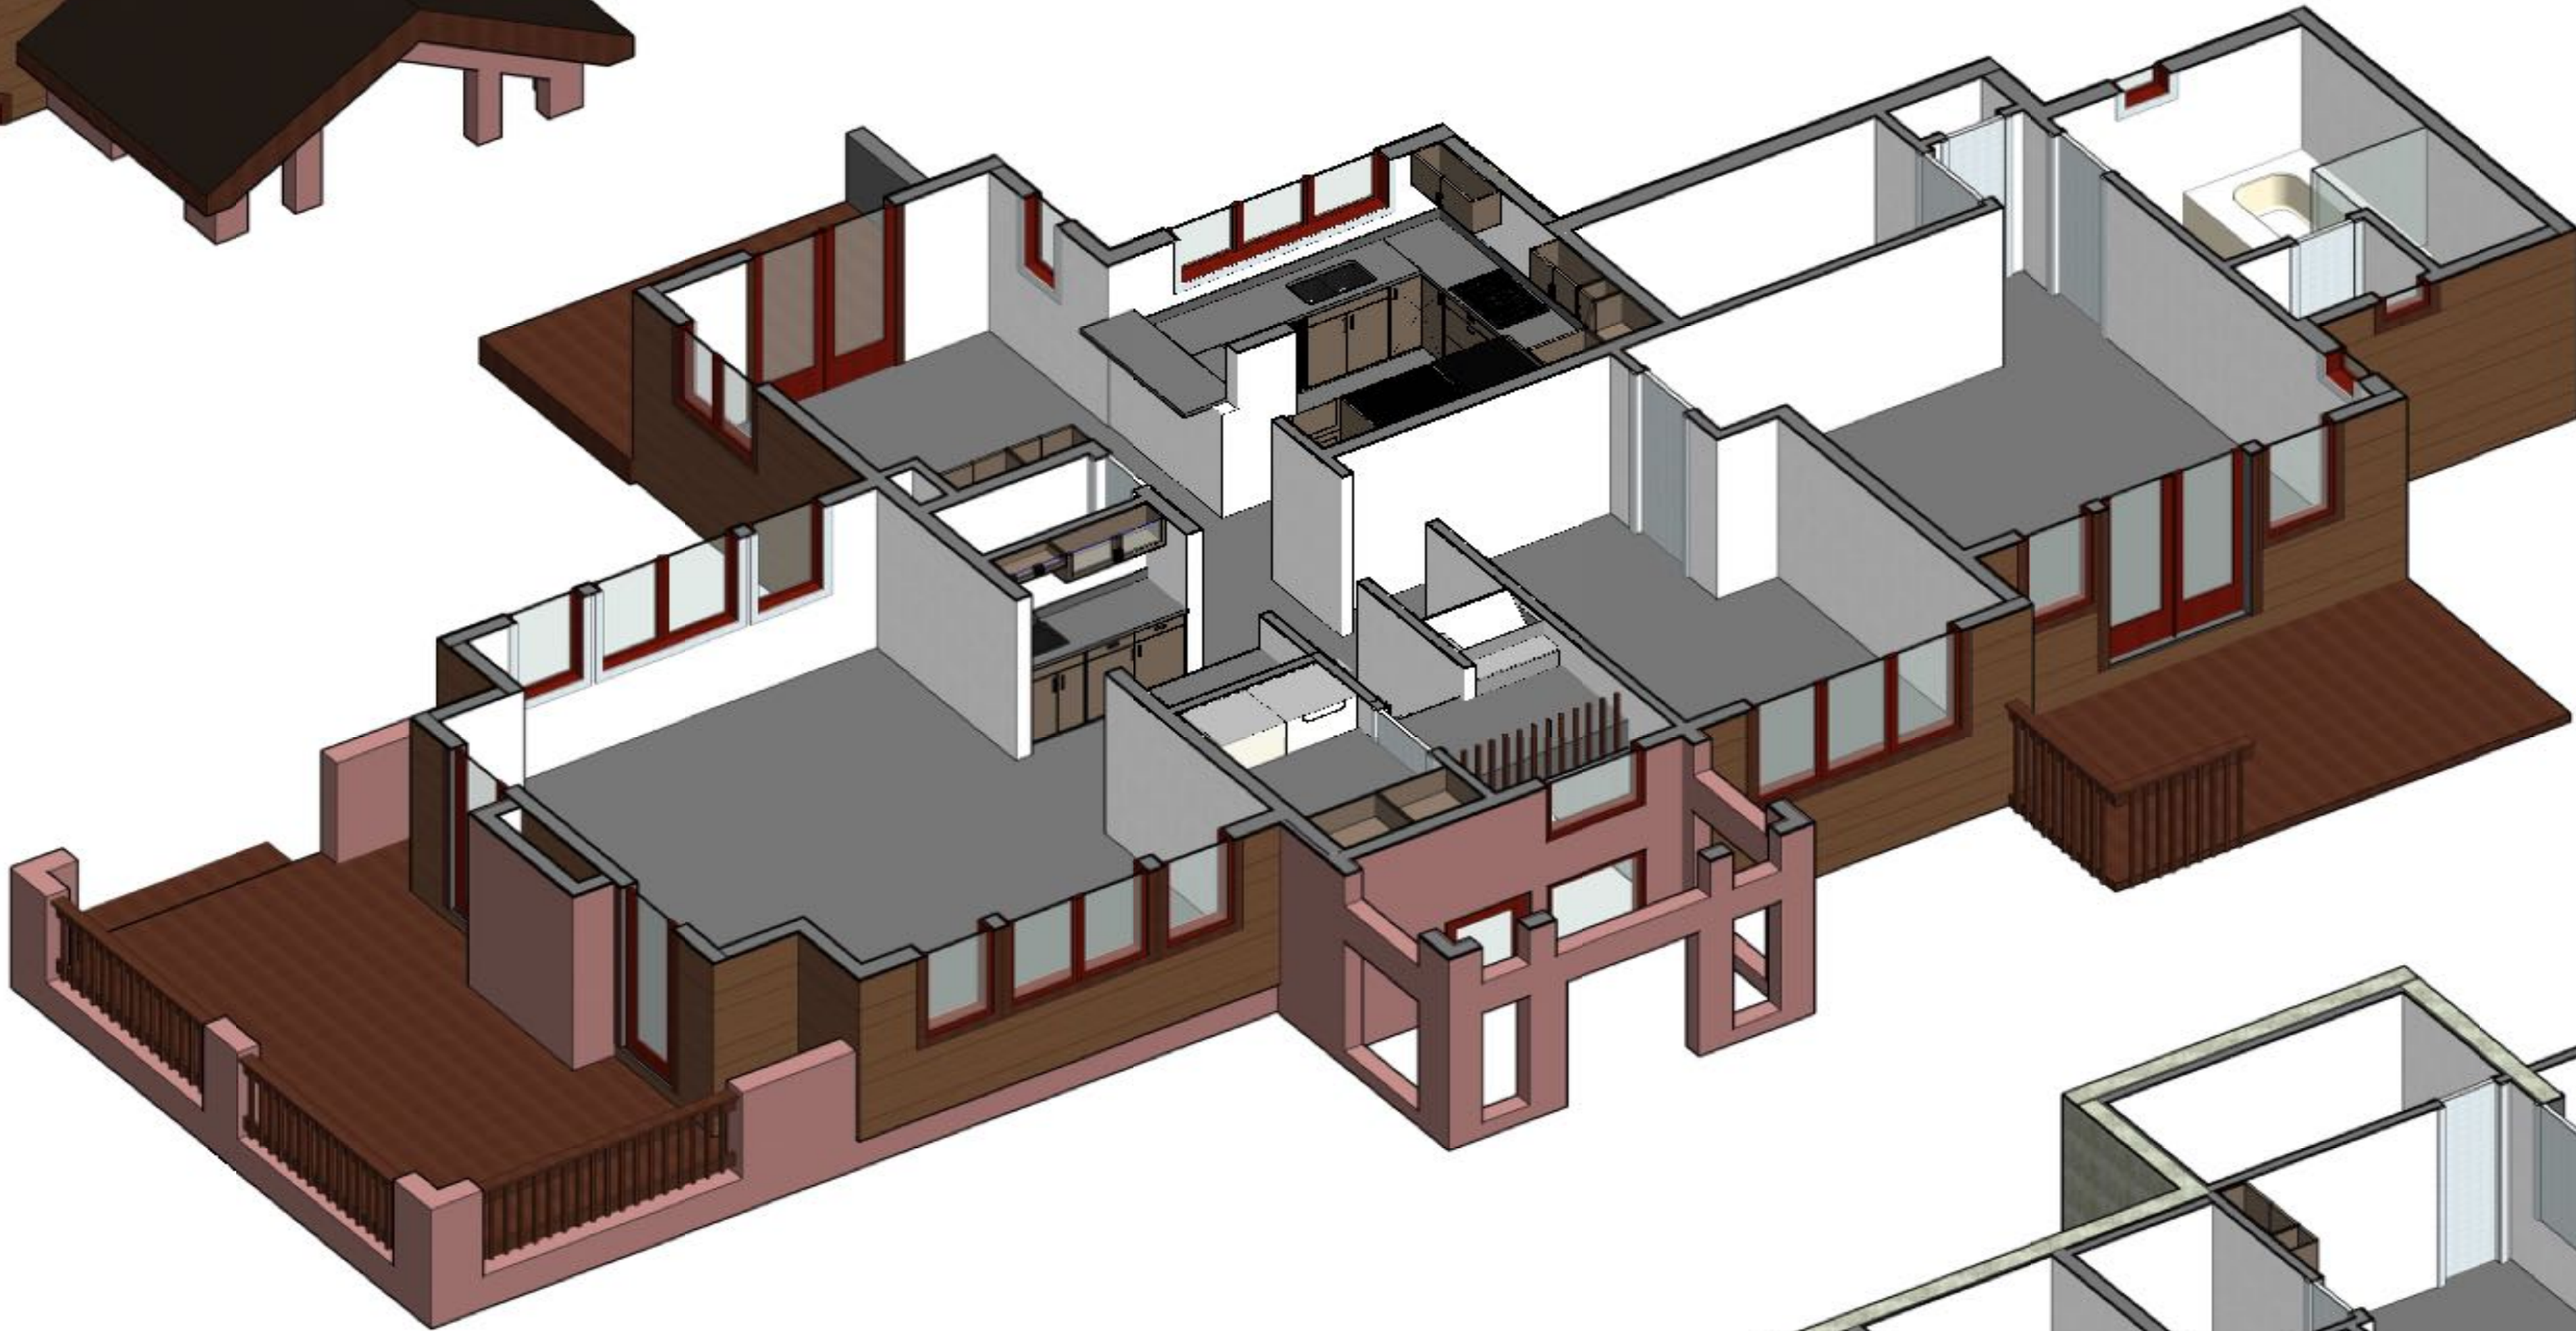

FIRST FLOOR

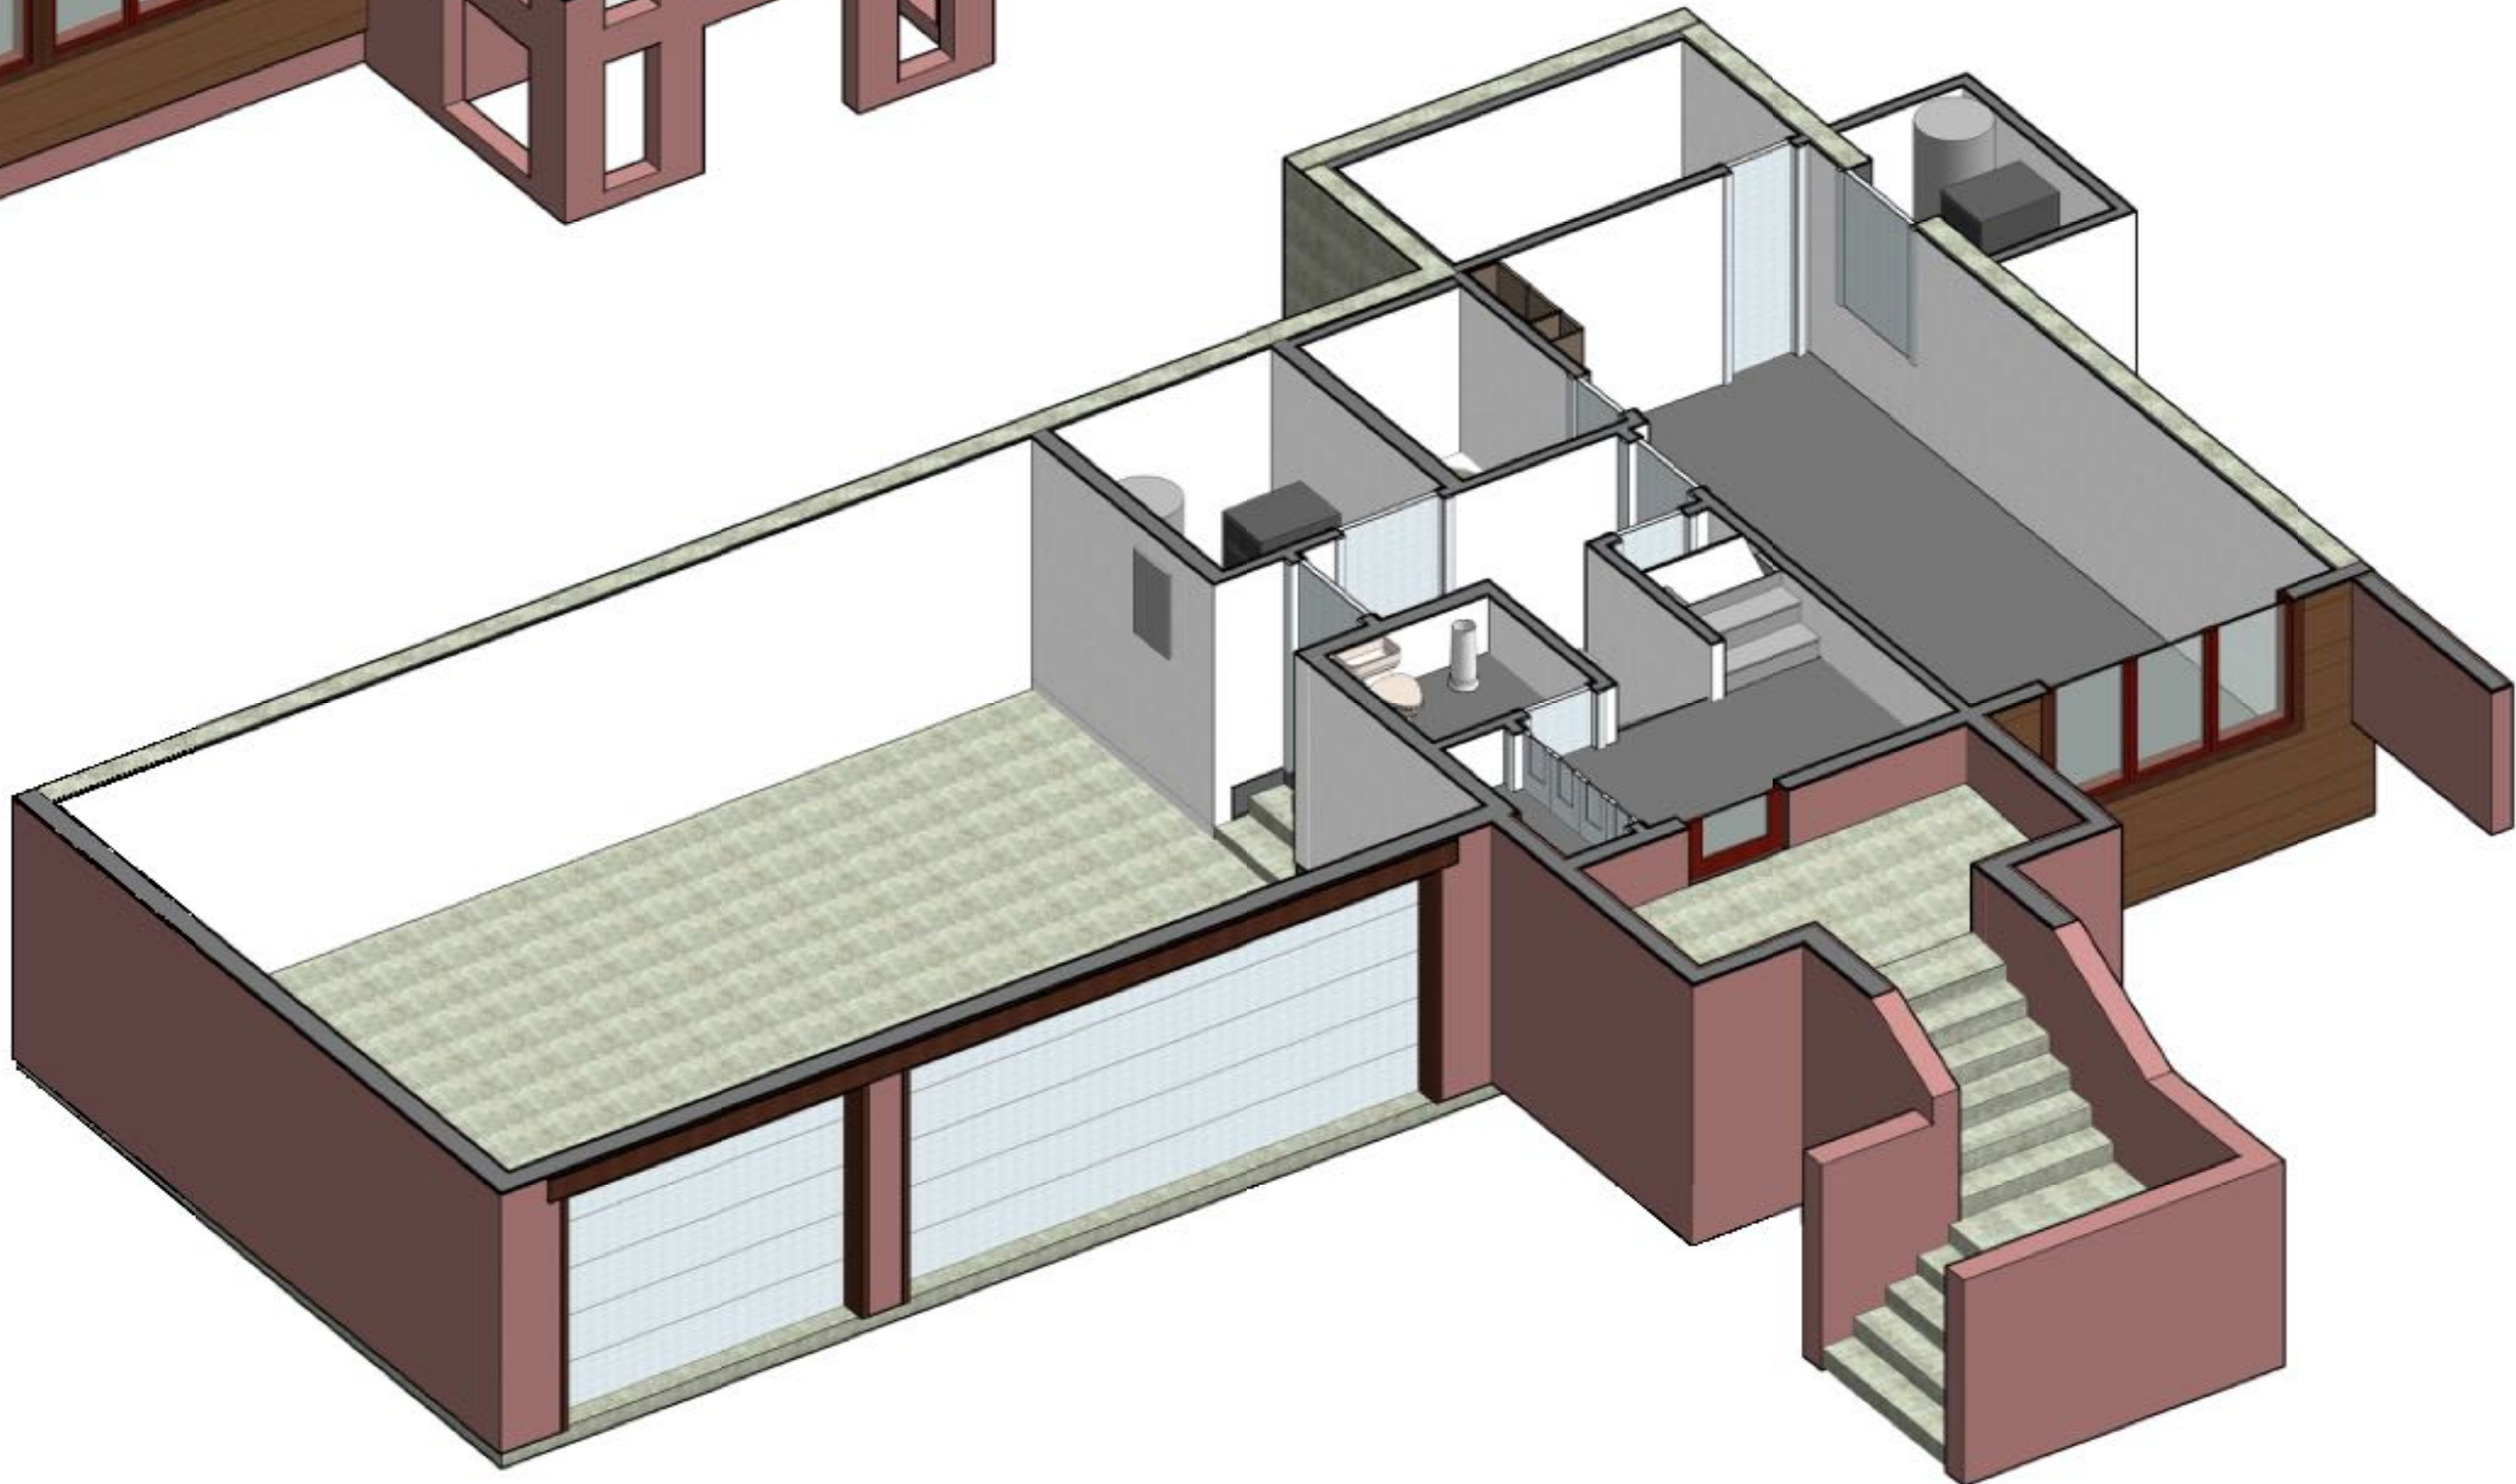

BASEMENT

As BUILT

PROFESSIONALS

www.asbuiltprofessionals.com

A DIVISION OF:

AEC

CONSULTANTS INC

844.272.8458

844 A S B U I L T

© 2020 AEC CONSULTANTS INC

ARCHITECTURAL AS BUILT

Edwards, CO 81632

01	100% SUBMISSION	SEE COVER SHEET
NO.	ISSUES / REVISIONS	DATE
SHEET TITLE		

3D SECTIONS

Designer	PROJECT MANAGER
Designer	PROJECT DIRECTOR
12317-1	PROJECT NUMBER
	SCALE
Author	DRAWN BY
	SHEET NUMBER