


AS-BUILT DOCUMENTATION

LAS VEGAS, NV 89109

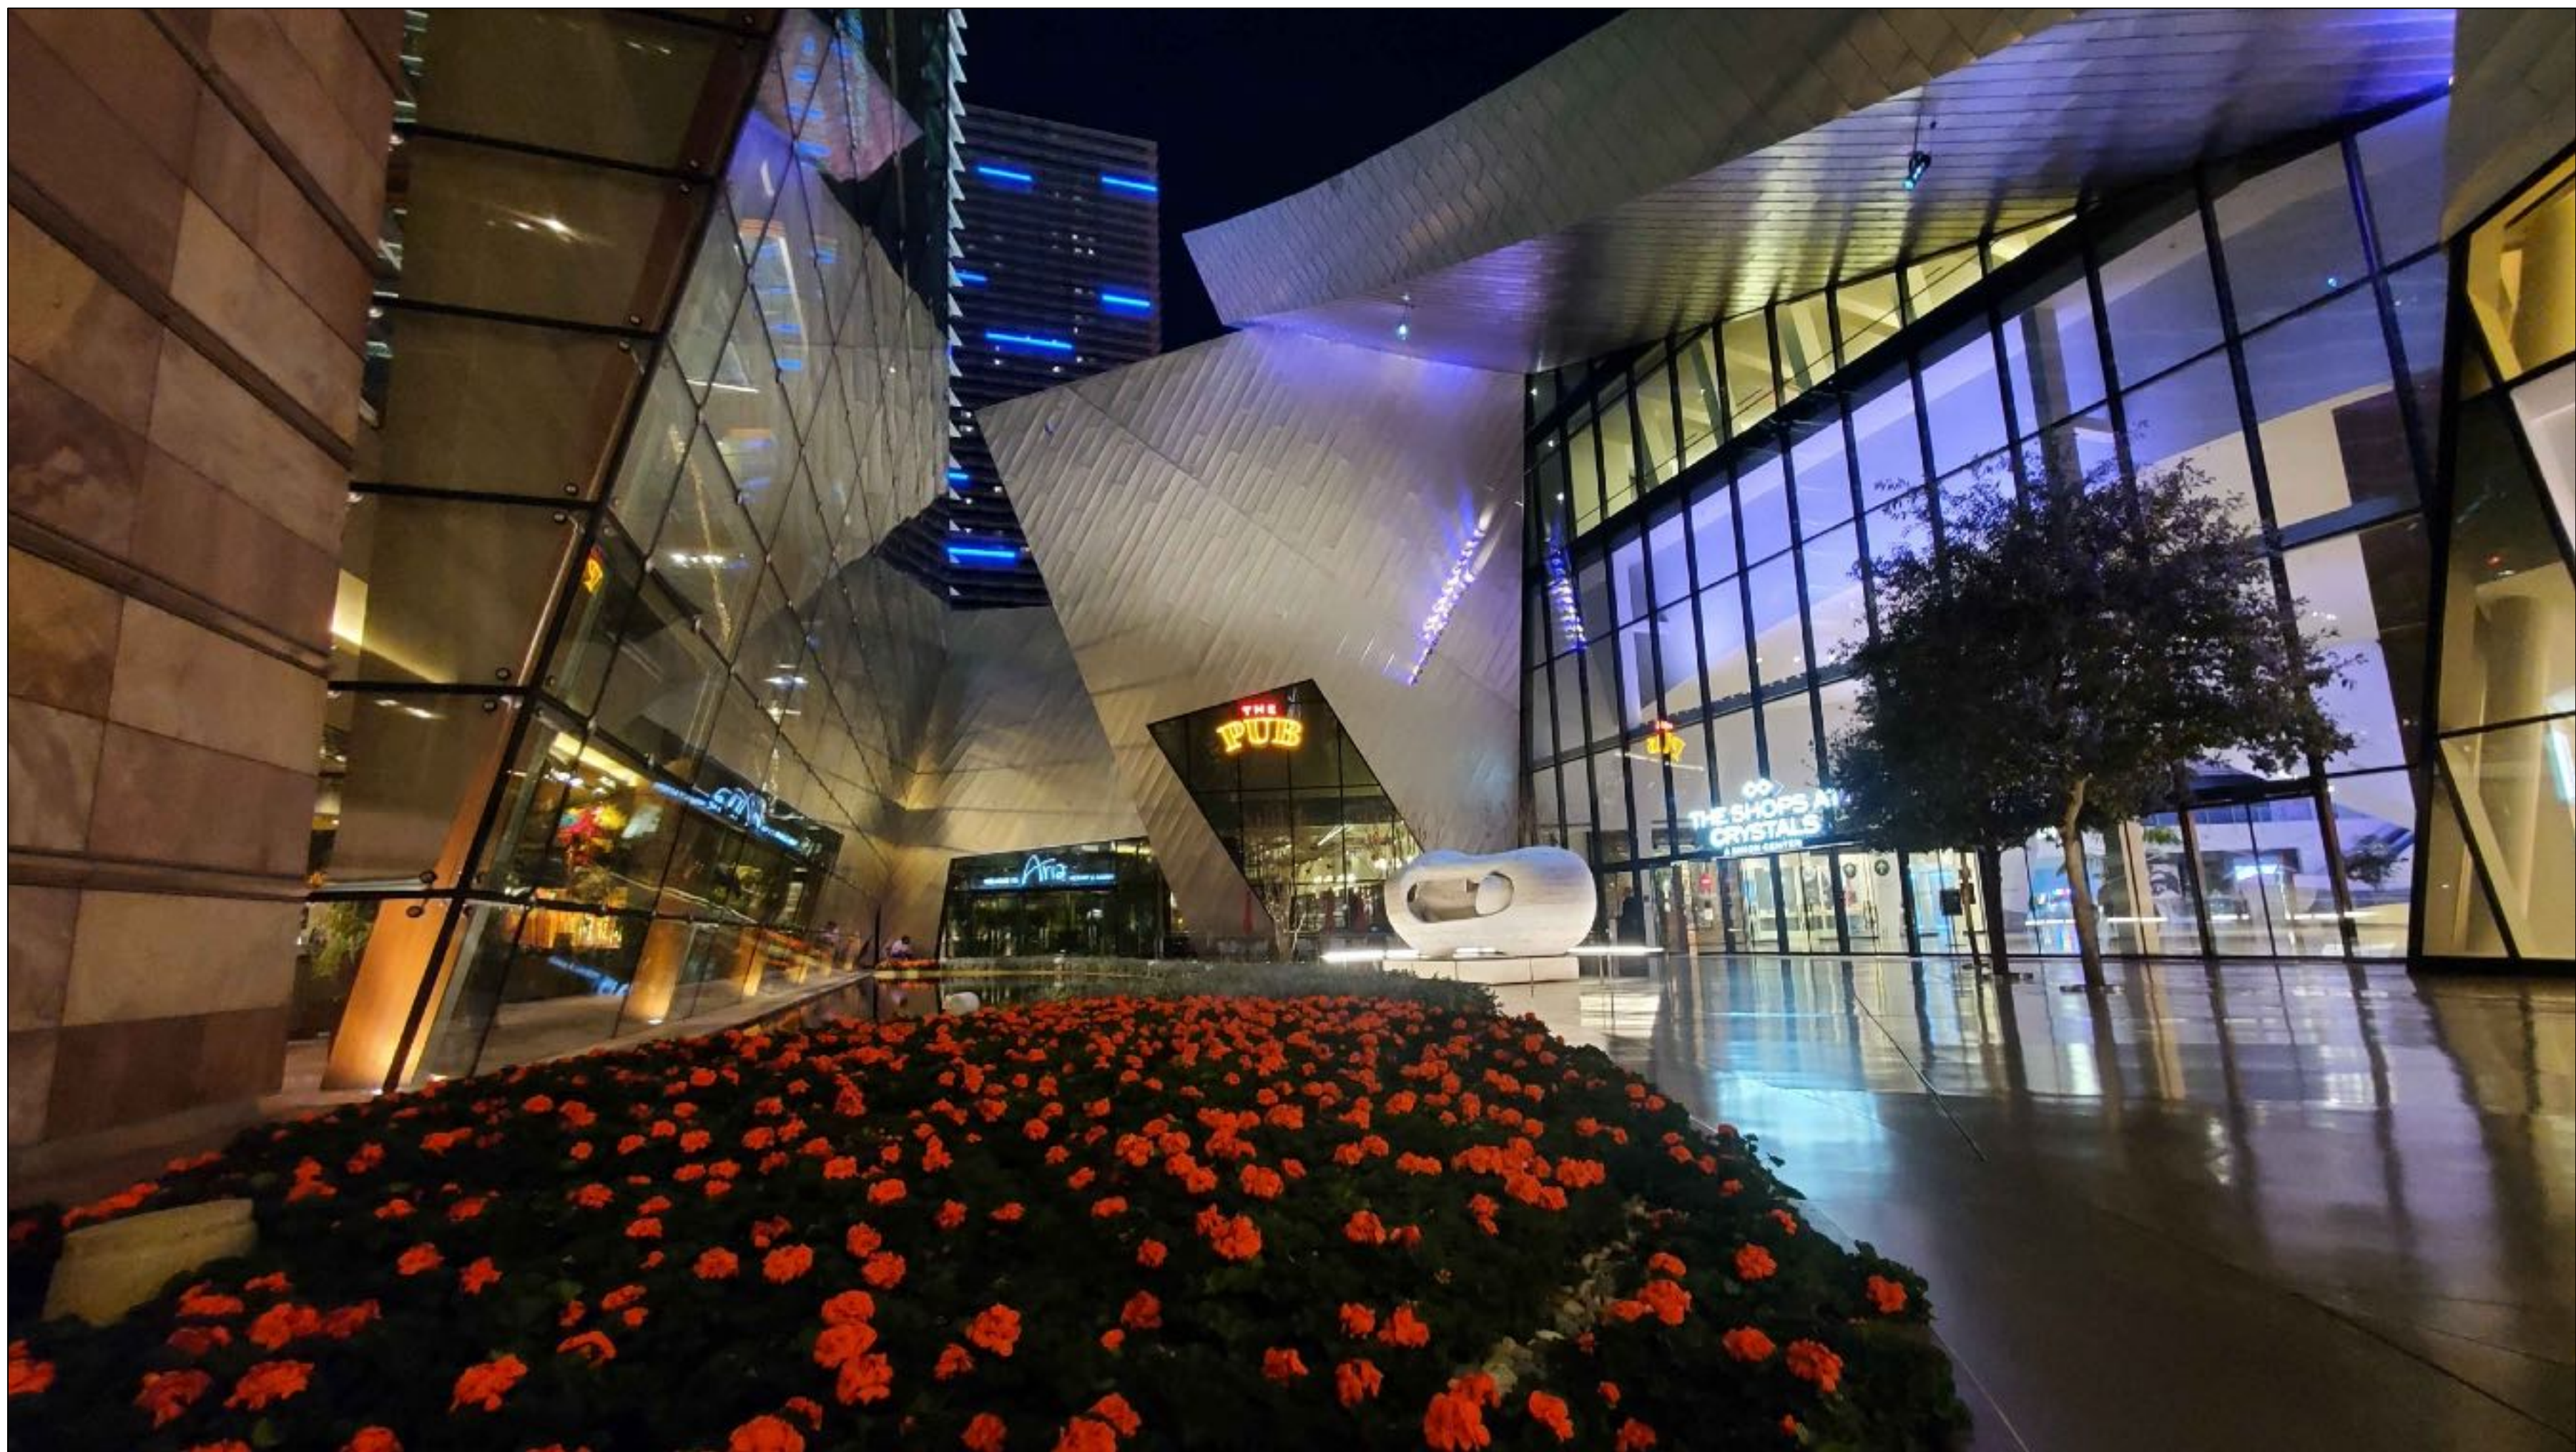



100% SUBMITTAL

DRAWING INDEX

C-1	COVER SHEET DRAWING INDEX
SL	SYMBOLS LEGEND
AB-1	SITE PLAN
AB-2	FLOORPLAN
AB-3	RCP
AB-4	ELEVATIONS

Scope of Work:

 - ✓ FLOOR PLANS (MEP) LOCATE VISIBLE MECHANICAL,
- ✓ ELECTRICAL AND PLUMBING ON WALLS AND FLOOR.
- ✓ FINISH SCHEDULE OF THE KITCHEN
- ✓ 2 EXTERIOR ELEVATIONS
- ✓ EXTERIOR FINISH SCHEDULE
- ✓ 4 INTERIOR ELEVATIONS
- ✓ REFLECTED CEILING PLAN (HEIGHTS, TRANSITIONS AND
- ✓ VISIBLE MEP ITEMS)
- ✓ MEP SCHEDULES
- ✓ SITE PLAN INCLUDING TREES AND TOPO

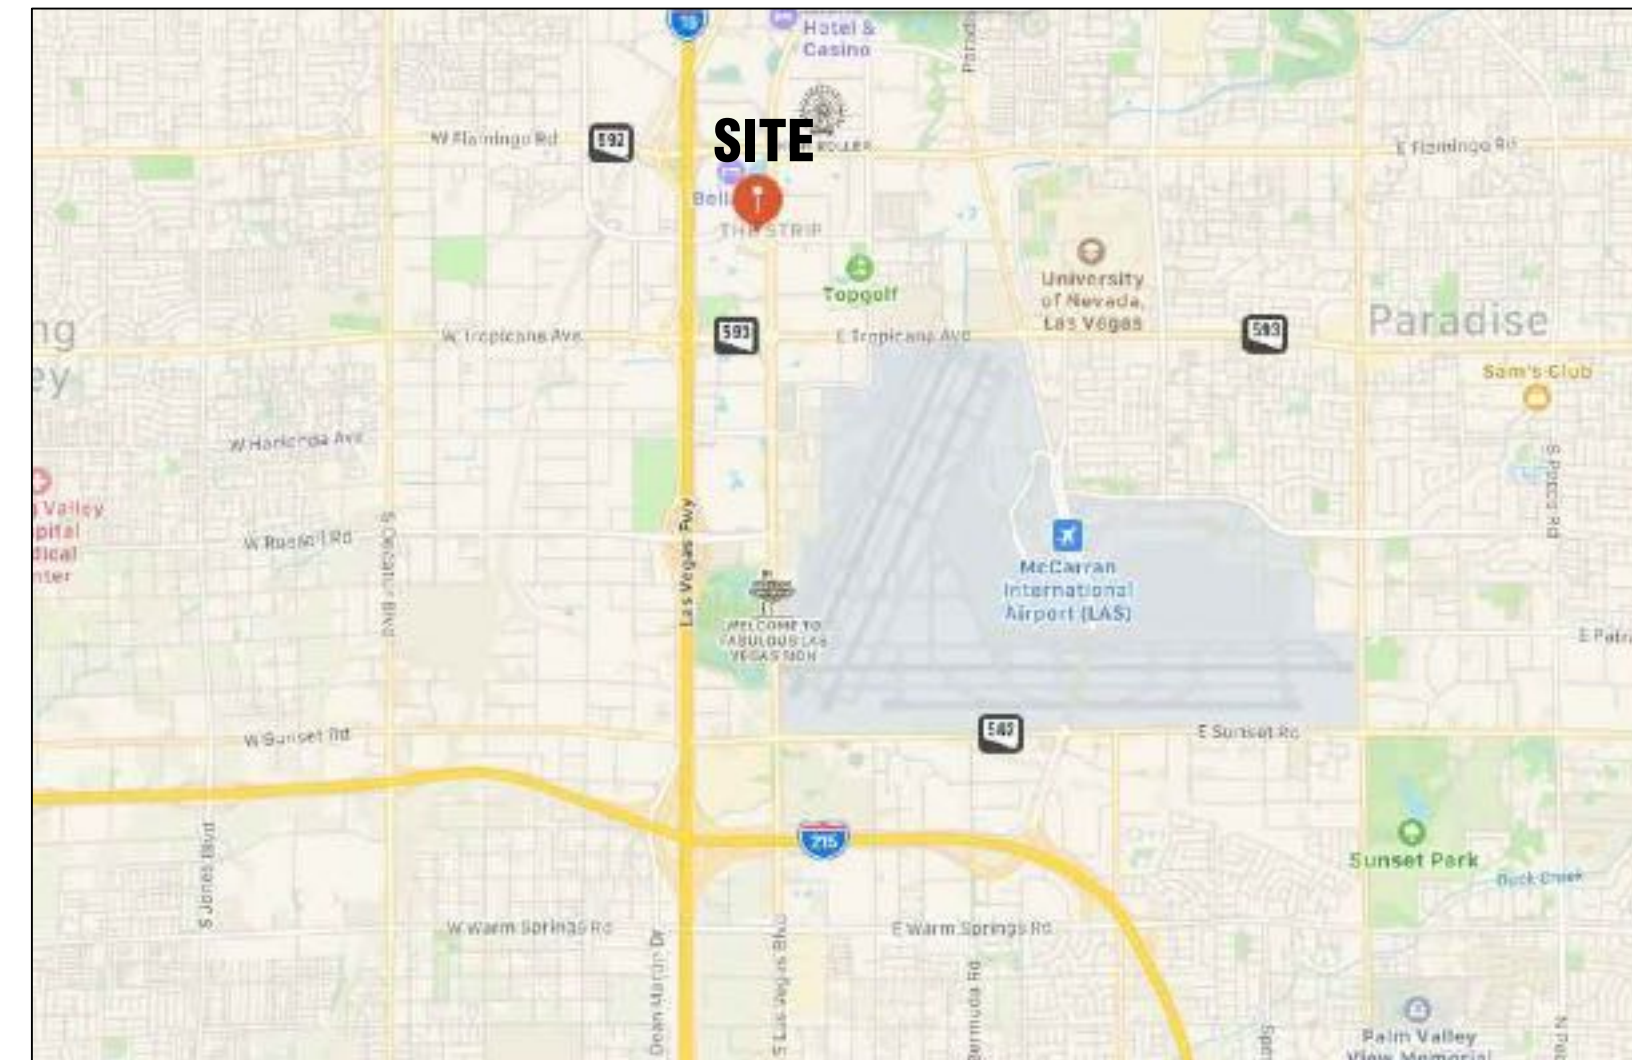

VICINITY MAP

GROSS AREA DATA	
MAIN FLOOR	9,538 S.F.
GRAND TOTAL	9,538 S.F.



© 2021 AEC CONSULTANTS INC

ARCHITECTURAL AS BUILT

LAS VEGAS, NV 89109

01	100% SUBMISSION	SEE COVER SHEET
NO.	ISSUES REVISIONS	DATE
		SHEET TITLE
COVER SHEET		
HL	PROJECT MANAGER	
HL	PROJECT DIRECTOR	
	PROJECT NUMBER	
	SCALE	
MM	DRAWN BY	
	SHEET NUMBER	

C-1

SYMBOLS LEGEND

RCP

	EXHAUST VENT		TRACK LIGHT OR VANITY LIGHT
	CEILING MOUNTED LIGHT FIXTURE		WALL-MOUNTED LIGHT FIXTURE
	CEILING MOUNTED DIRECTIONAL LIGHT		EMERGENCY EXIT SIGN
	RECESSED CAN LIGHT		EMERGENCY EXIT LIGHT
	EYEBALL OR SMALL CAN LIGHT		EMERGENCY EXIT LIGHT W/ SIGN
	PENDANT LIGHT		LIGHT FIXTURE
	INDIVIDUAL FLUOR. LAY-IN FIXTURE 4 BULB		FLOOD LIGHT
	INDIVIDUAL FLUOR. HANGING FIXTURE 2 BULB		PHOTO CELL
	INDIVIDUAL FLUOR. FLUSH MOUNT FIXTURE 4 BULB		CEILING FAN
	WIFI ROUTER		CEILING FAN W/ LIGHT KIT
	CAMERA	<p>7-2-6</p>	CEILING HEIGHT AND TRIM 7'-2" ABOVE FLOOR BELOW WITH 6" CROWN MOULDING. NOTE: ALL CEILINGS NOT LABELED ARE PLASTER. CEILINGS SHOWN WITH A GRID ARE LAY IN ACOUSTICAL TILE..
	MOTION DET.		JUNCTION BOX
	SUPPLY VENT		
	SUPPLY VENT		
	RETURN VENT		
	RETURN VENT		
	SPEAKER		

ELECTRIC

	DATA OUTLET
	TELEPHONE JACK
	ELECTRIC SWITCH
	CABLE TELEVISION OUTLET
	DUPLEX RECEPTACLE OUTLET
	SPECIAL PURPOSE CONNECTION OR OUTLET
	QUADRUPLIX RECEPTACLE OUTLET
	FLOOR DUPLEX RECEPTACLE OUTLET
	ELECTRIC PANEL
	ELECTRIC METER
	BUTTON SWITCH
	DISCONNECT SWITCH
	TABLE LAMP
	GROUND/FLOOR LIGHT
	KEY PAD

FIRE PROTECTION


	FIRE EXTINGUISHER
	FIRE PULL
	FIRE ALARM (HORN/SRTOBE)
	SMOKE DETECTOR
	SMOKE ALARM SPEAKER
	SPRINKLER HEAD CEILING MOUNT
	SPRINKLER HEAD WALL MOUNT

MEP


	THERMOSTAT
	FLOOR DRAIN
	VALVE
	HOSE BIB
	WATER SUPPLY
	SUSPENDED GAS HEATER

MISC


	BOLLARD
	11-4-11/16SPOT ELEVATION

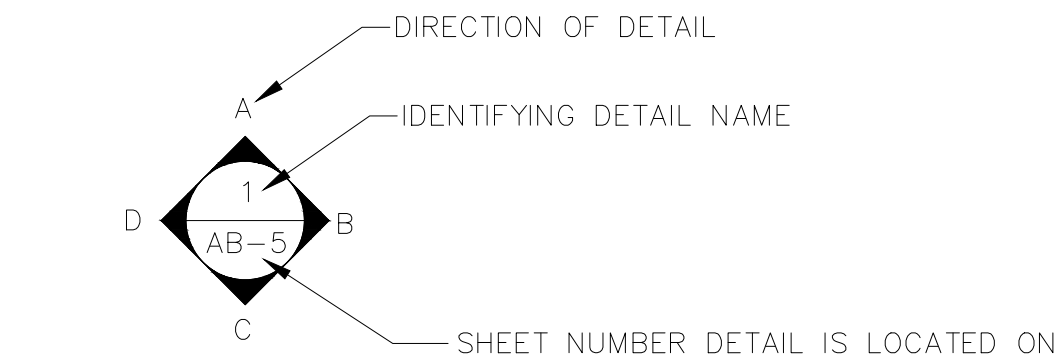

INTERIOR ELEVATIONS

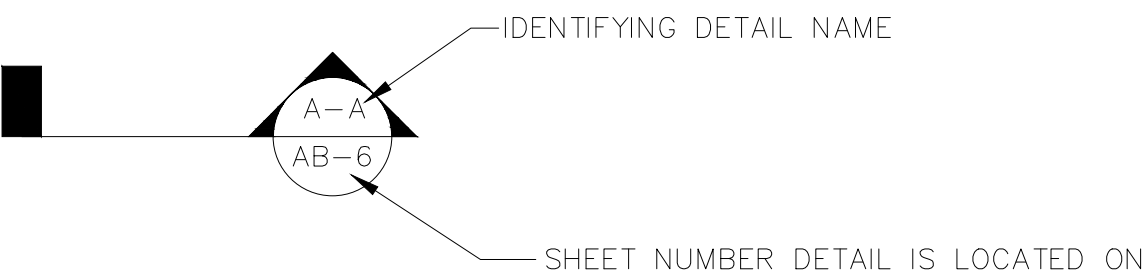

BUILDING SECTION

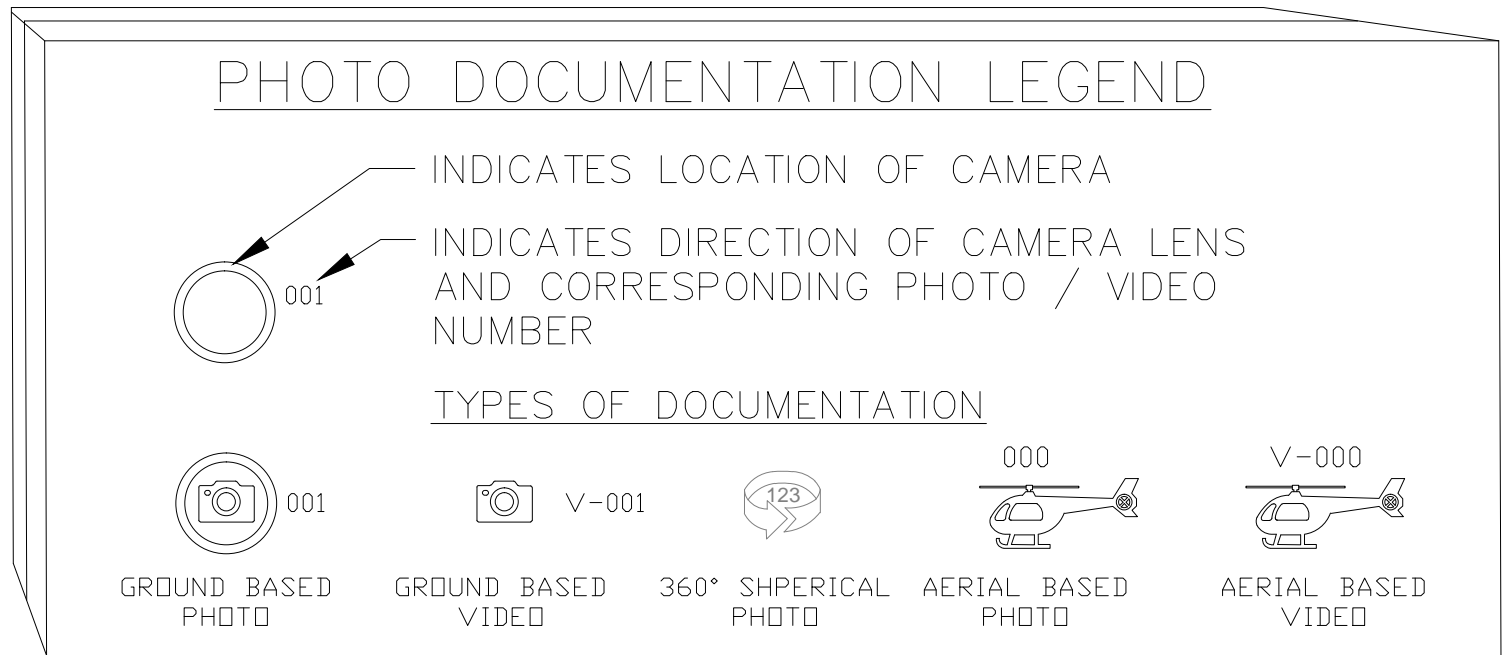

AS BUILT PROFESSIONALS

www.asbuiltprofessionals.com

A DIVISION OF:

AEC

CONSULTANTS INC

844.272.8458

844 AS BUILT

© 2021 AEC CONSULTANTS, INC

ARCHITECTURAL AS BUILT



LAS VEGAS, NV 89109

01	100% SUBMISSION	SEE COVER SHEET
NO.	ISSUES REVISIONS	DATE
SHEET TITLE		
HL	PROJECT MANAGER	
HL	PROJECT DIRECTOR	
	PROJECT NUMBER	
NOT TO SCALE		SCALE
MM	DRAWN BY	
	SHEET NUMBER	

SL

ARCHITECTURAL AS BUILT

LAS VEGAS, NV 89109

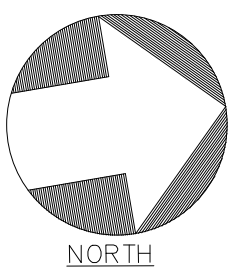
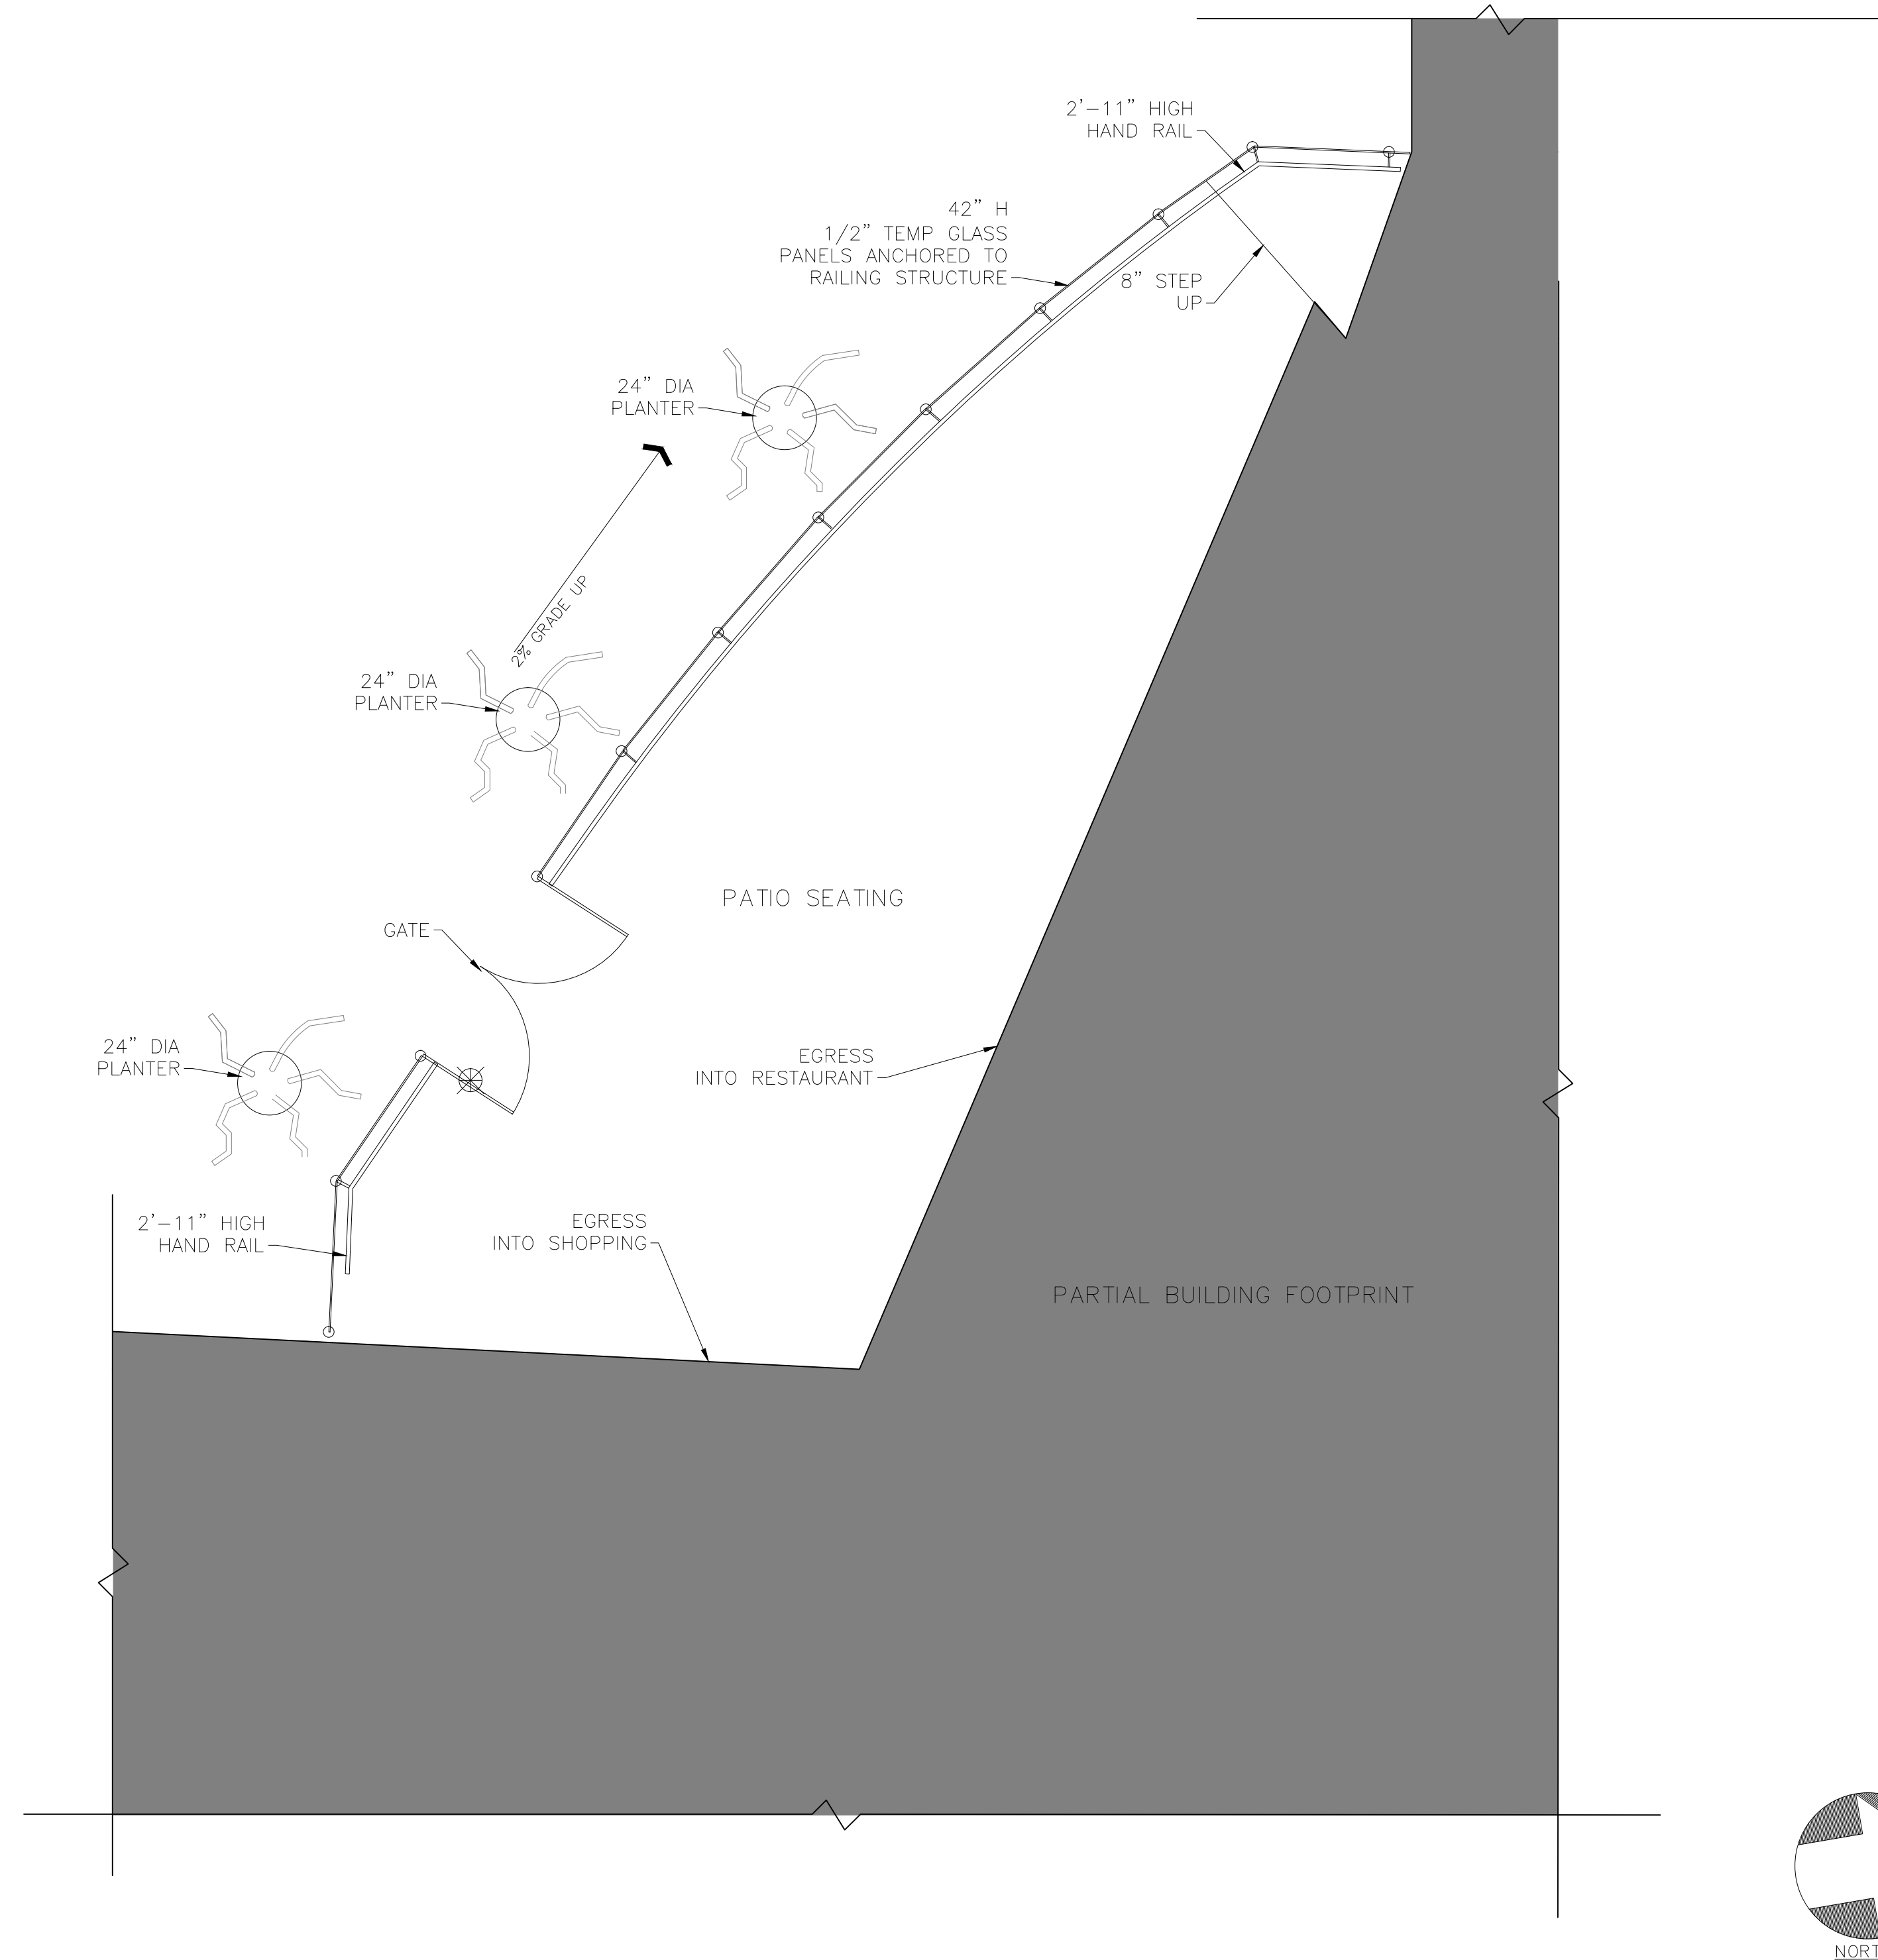


01	100% SUBMISSION	SEE COVER SHEET
NO.	ISSUES REVISIONS	DATE
		SHEET TITLE
SITE PLAN		
HL		PROJECT MANAGER
HL		PROJECT DIRECTOR
		PROJECT NUMBER
1/4"=1'-0"		SCALE
MM		DRAWN BY
		SHEET NUMBER

AB-1

ARCHITECTURAL AS BUILT
LAS VEGAS, NV 89109

KITCHEN FINISH SCHEDULE			
ROOM NAME	FLOOR	WALLS	CEILING
OFFICE	6" TILE	FIRE RESISTANT PANEL	2' X'2' CEILING TILE
WALK-IN FRIDGE	6" TILE	METAL	METAL
WALK-IN FREEZER	6" TILE	METAL	METAL
CHILLER 1	6" TILE	METAL	METAL
CHILLER 2	6" TILE	METAL	METAL
DRY STORAGE	6" TILE	FIRE RESISTANT PANEL	2' X'2' CEILING TILE
RESTROOM 1	6" TILE	FRP 48" WAINSCOT/PAINTED DRYWALL	PAINTED DRYWALL
RESTROOM 2	6" TILE	FRP 48" WAINSCOT/PAINTED DRYWALL	PAINTED DRYWALL
KITCHEN - ALL OTHER AREAS	6" TILE	FIRE RESISTANT PANEL	2' X'2' CEILING TILE

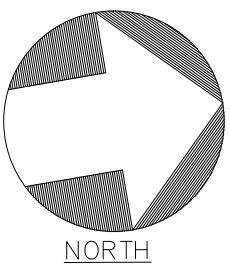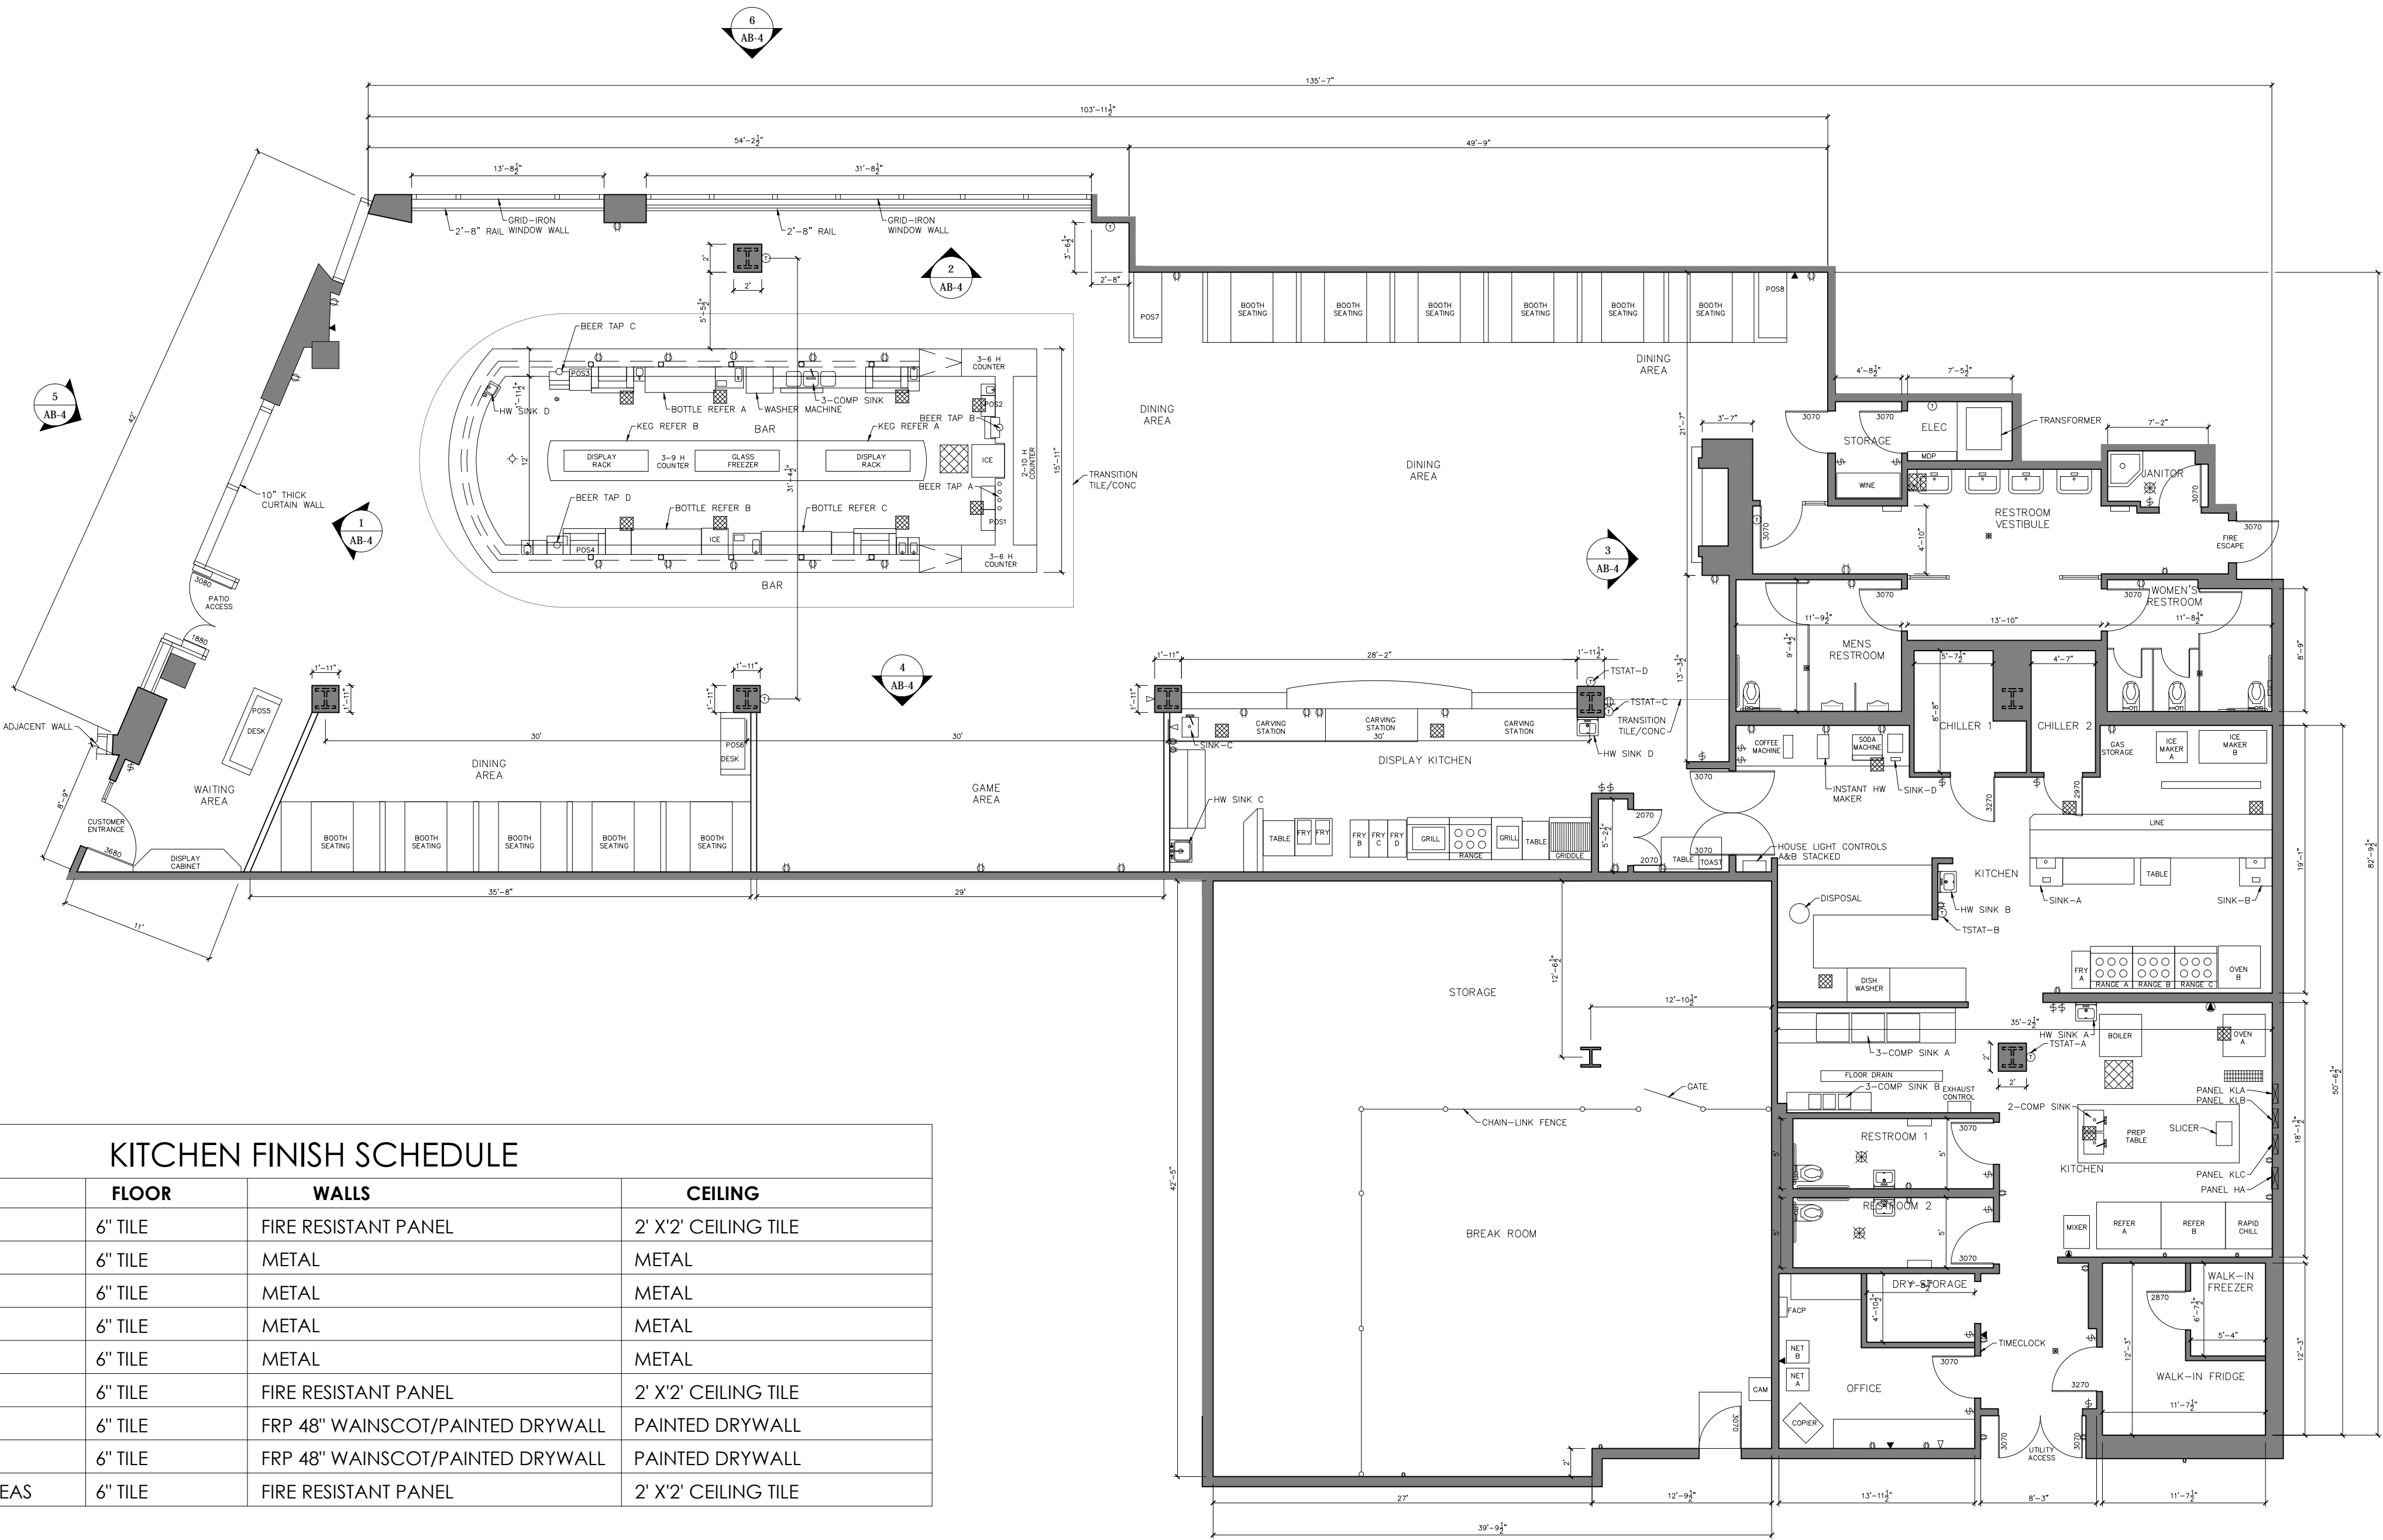


01	100% SUBMISSION	SEE COVER SHEET
NO.	ISSUES REVISIONS	DATE

FLOOR
PLAN

HL	PROJECT MANAGER
HL	PROJECT DIRECTOR
	PROJECT NUMBER
1/8"=1'-0"	SCALE
MM	DRAWN BY
	SHEET NUMBER

AB-2

ARCHITECTURAL AS BUILT
LAS VEGAS, NV 89109

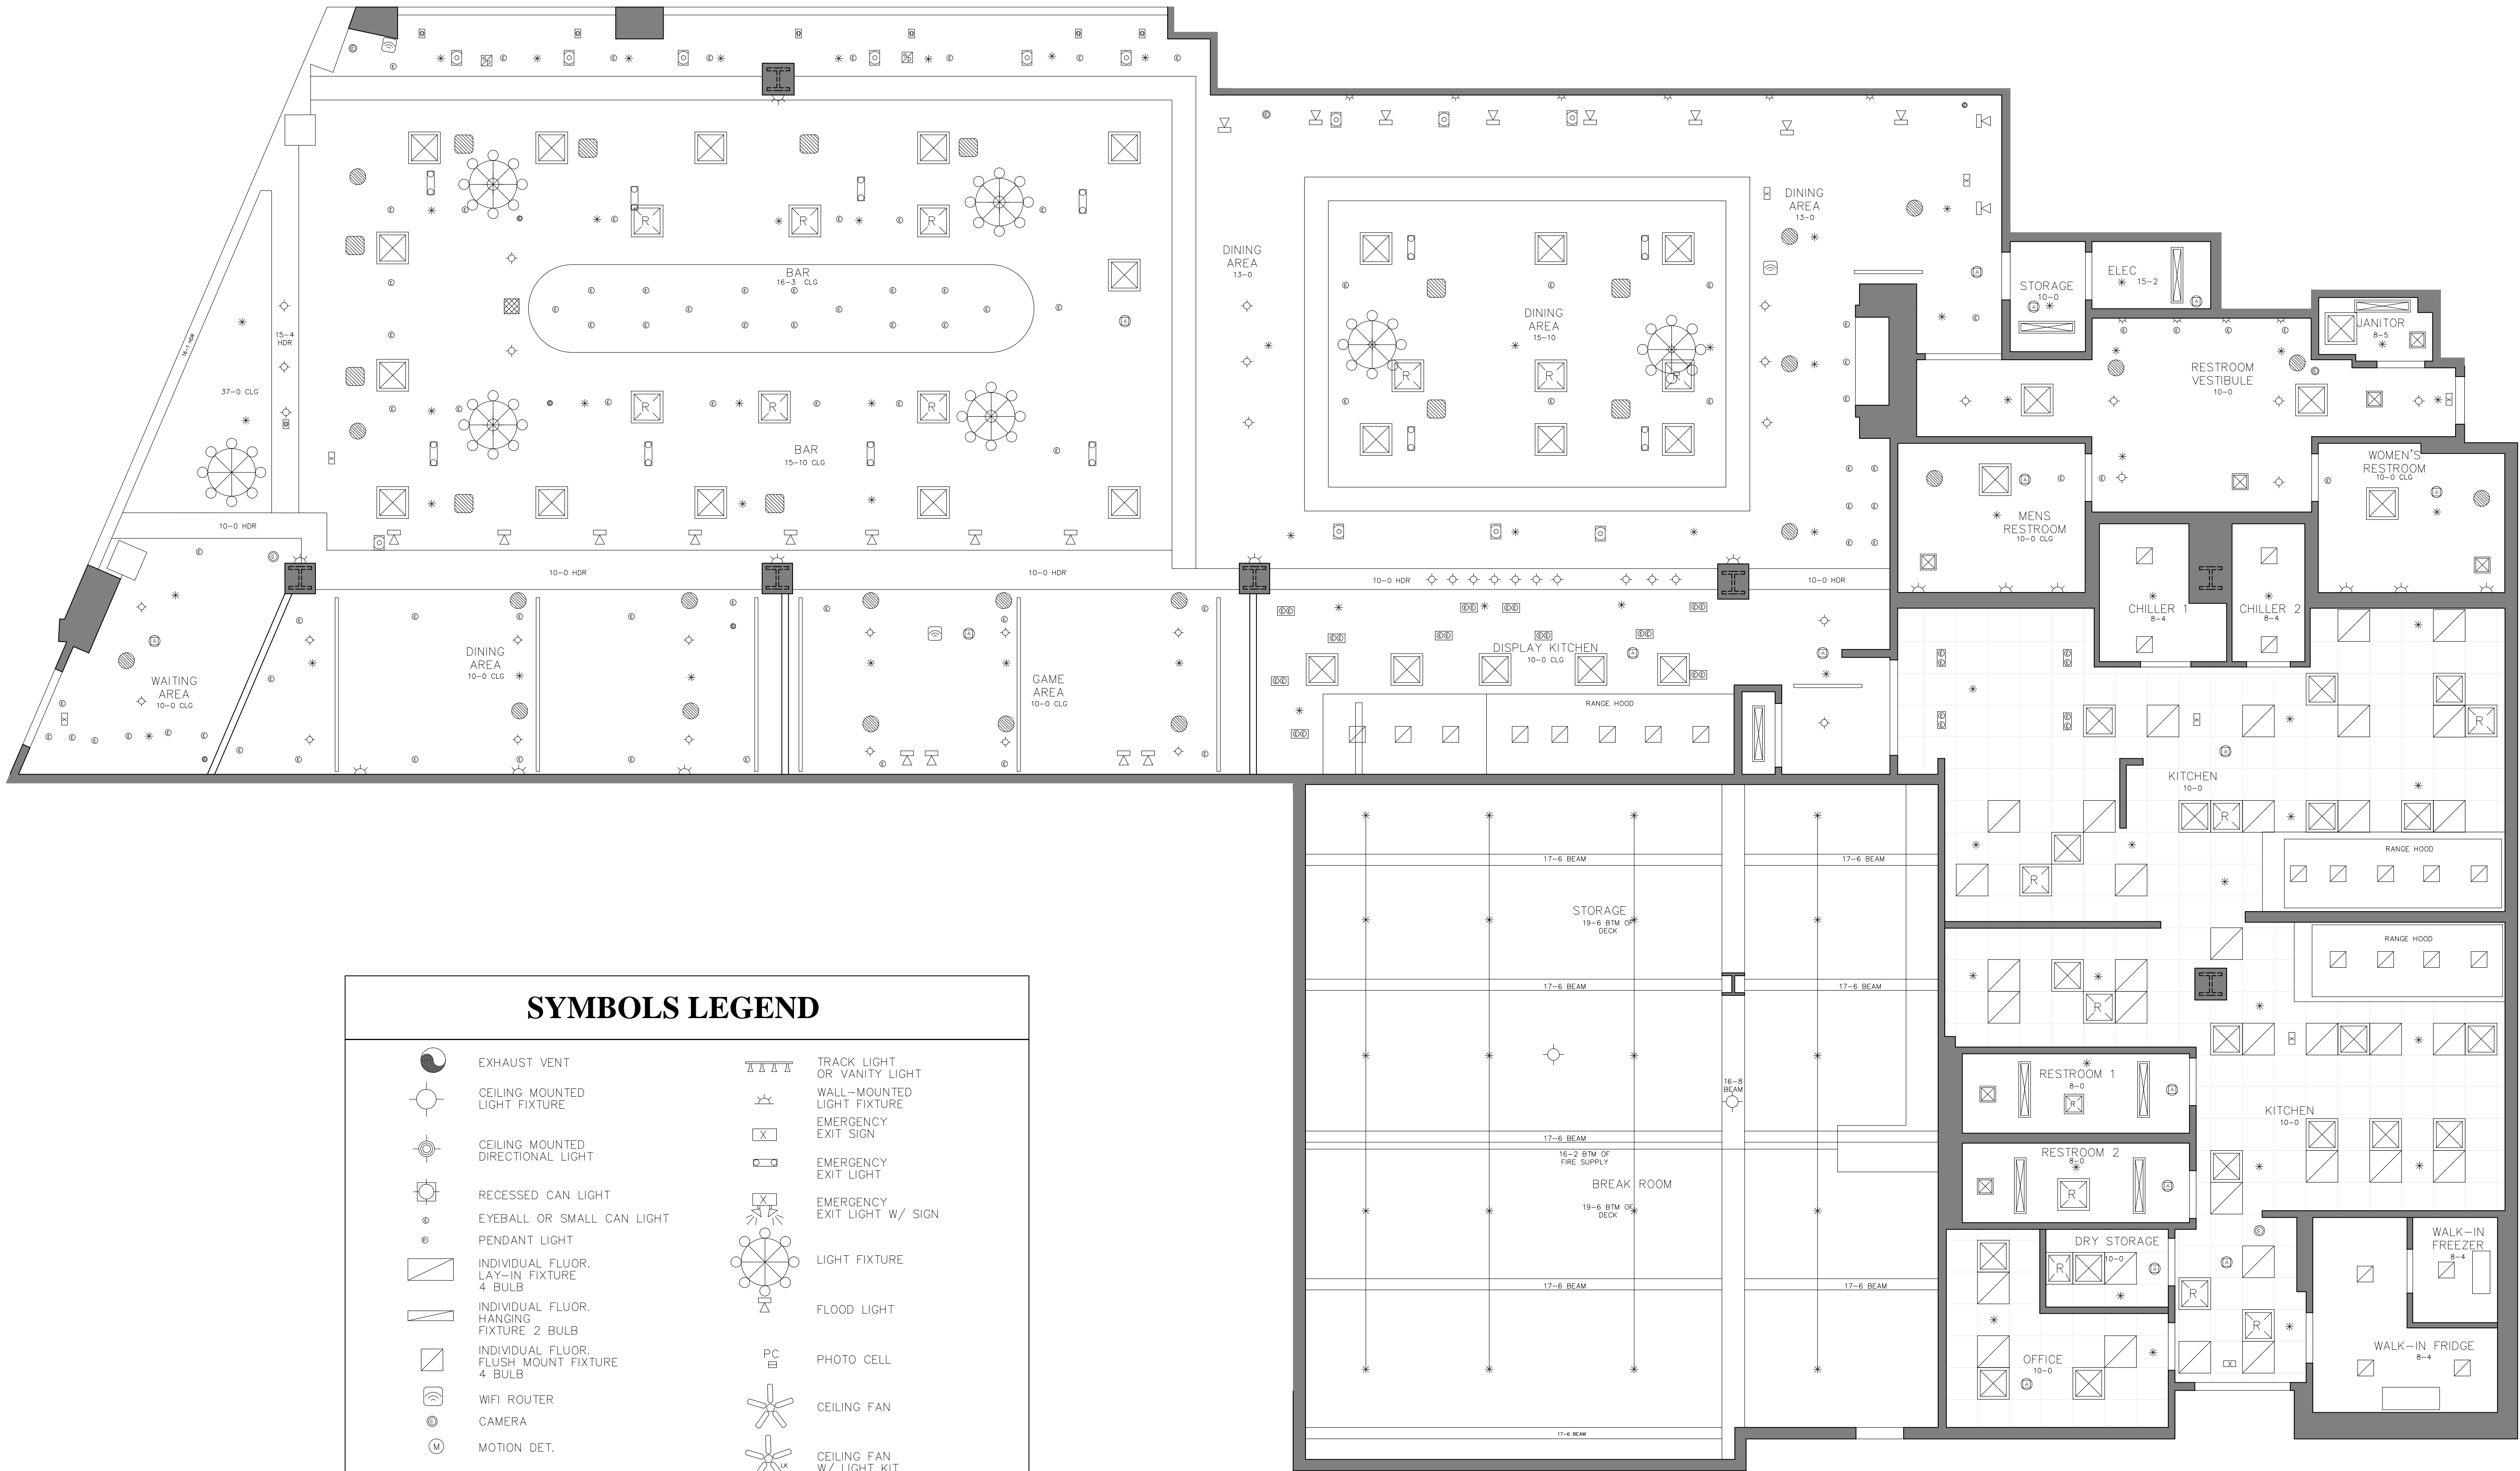


SYMBOLS LEGEND

- | | | | |
|--|--|--|------------------------------|
| | EXHAUST VENT | | TRACK LIGHT OR VANITY LIGHT |
| | CEILING MOUNTED LIGHT FIXTURE | | WALL-MOUNTED LIGHT FIXTURE |
| | CEILING MOUNTED DIRECTIONAL LIGHT | | EMERGENCY EXIT SIGN |
| | RECESSED CAN LIGHT | | EMERGENCY EXIT LIGHT |
| | EYEBALL OR SMALL CAN LIGHT | | EMERGENCY EXIT LIGHT W/ SIGN |
| | PENDANT LIGHT | | LIGHT FIXTURE |
| | INDIVIDUAL FLUOR. LAY-IN FIXTURE 4 BULB | | FLOOD LIGHT |
| | INDIVIDUAL FLUOR. HANGING FIXTURE 2 BULB | | PHOTO CELL |
| | INDIVIDUAL FLUOR. FLUSH MOUNT FIXTURE 4 BULB | | CEILING FAN |
| | WIFI ROUTER | | CEILING FAN W/ LIGHT KIT |
| | CAMERA | | |
| | MOTION DET. | | |
| | SUPPLY VENT | | |
| | SUPPLY VENT | | |
| | RETURN VENT | | |
| | RETURN VENT | | |
| | SPEAKER | | |

7-2-6
CEILING HEIGHT AND TRIM 7'-2" ABOVE FLOOR BELOW WITH 6" CROWN MOULDING. NOTE: ALL CEILINGS NOT LABELED ARE PLASTER. CEILINGS SHOWN WITH A GRID ARE LAY IN ACOUSTICAL TILE..

JUNCTION BOX

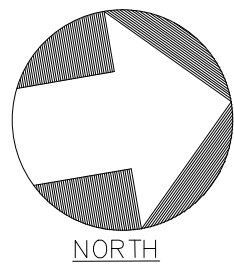

01	100% SUBMISSION	SEE COVER SHEET
NO.	ISSUES REVISIONS	DATE
		SHEET TITLE

RCP






HL	PROJECT MANAGER
HL	PROJECT DIRECTOR
	PROJECT NUMBER
3/16"=1'-0"	SCALE
MM	DRAWN BY
	SHEET NUMBER

AB-3

ARCHITECTURAL AS BUILT

LAS VEGAS, NV 89109

FINISH SCHEDULE	
KEY	TYPE
1	TILE
2	GLAZING CURTAIN WALL
3	ALUMINUM CLADDING
4	PAINTED SHEET ROCK
5	GLAZING GRID IRON
6	CAMERA
7	LIGHT FIXTURE
8	SMOKE DETECTOR

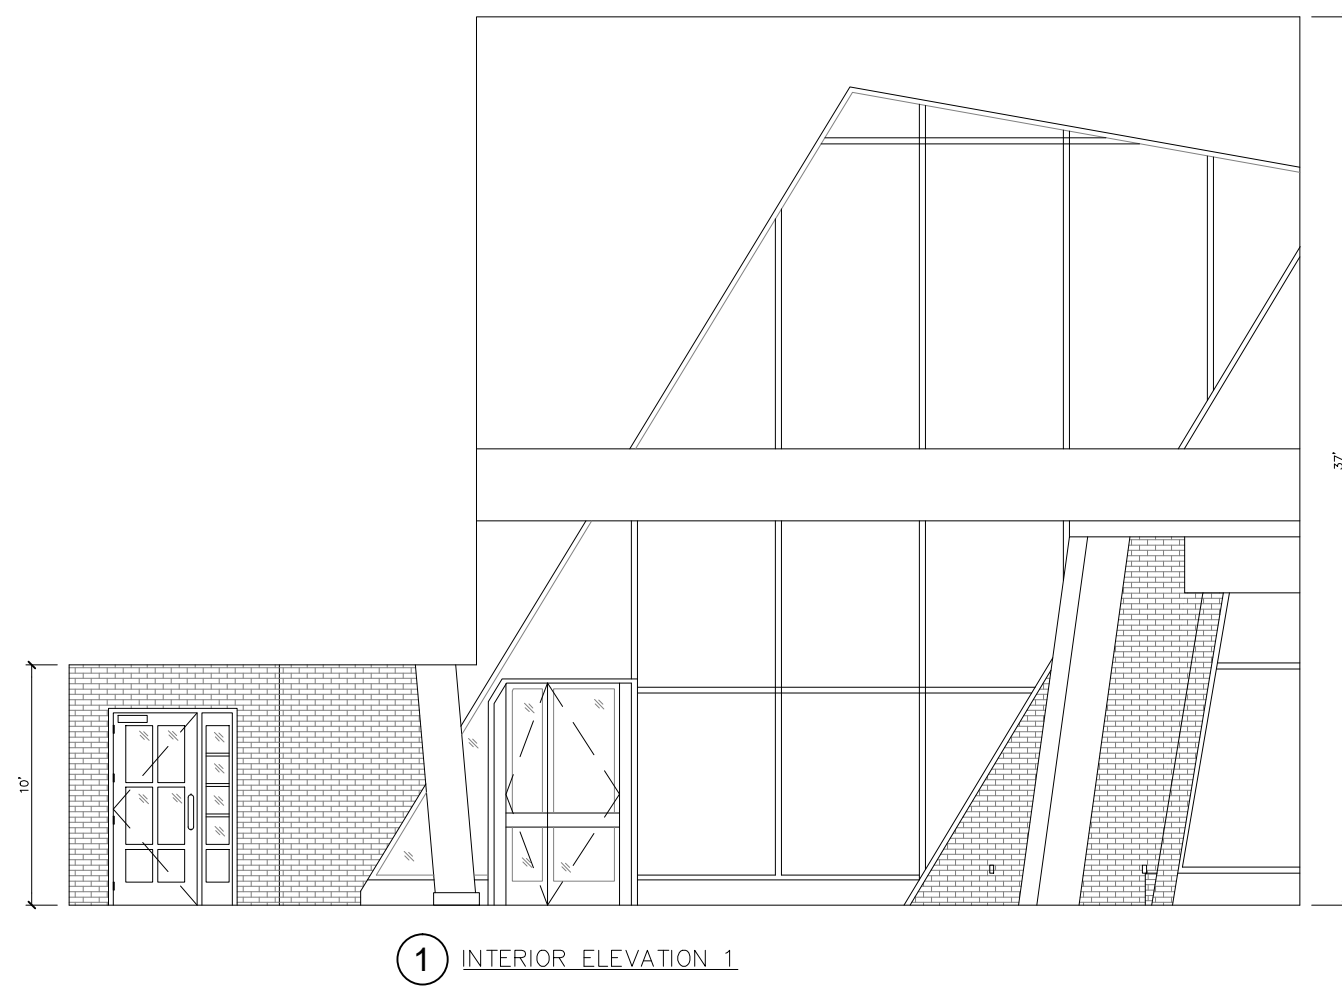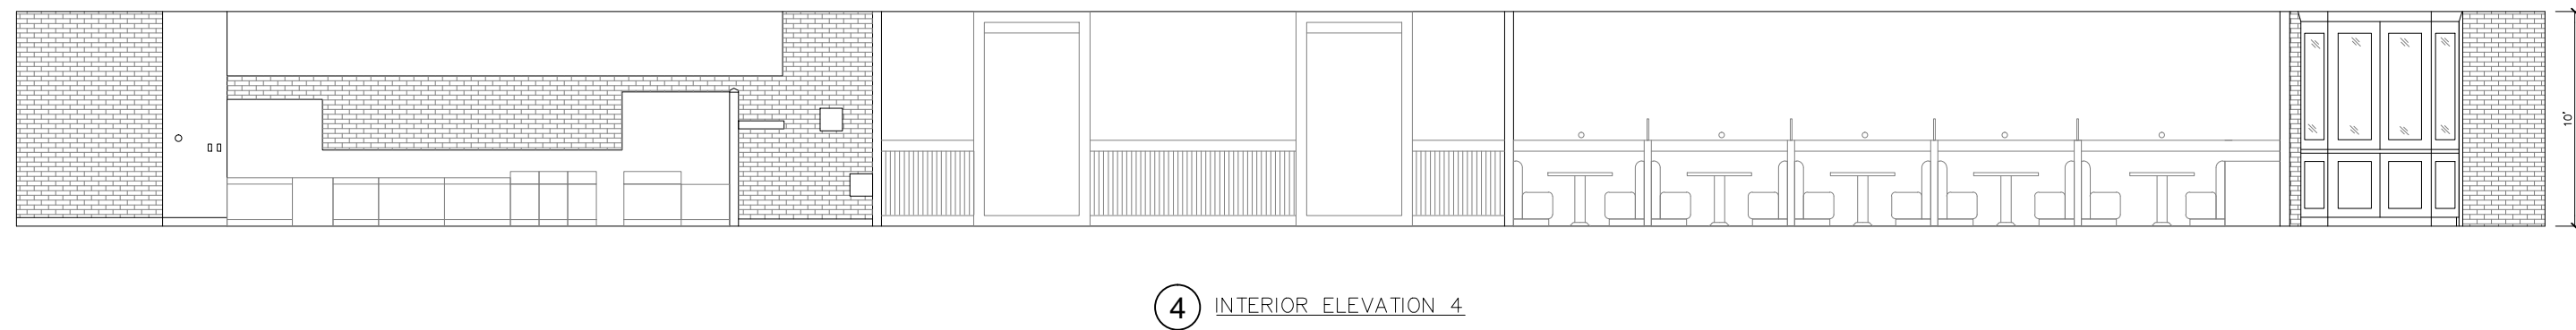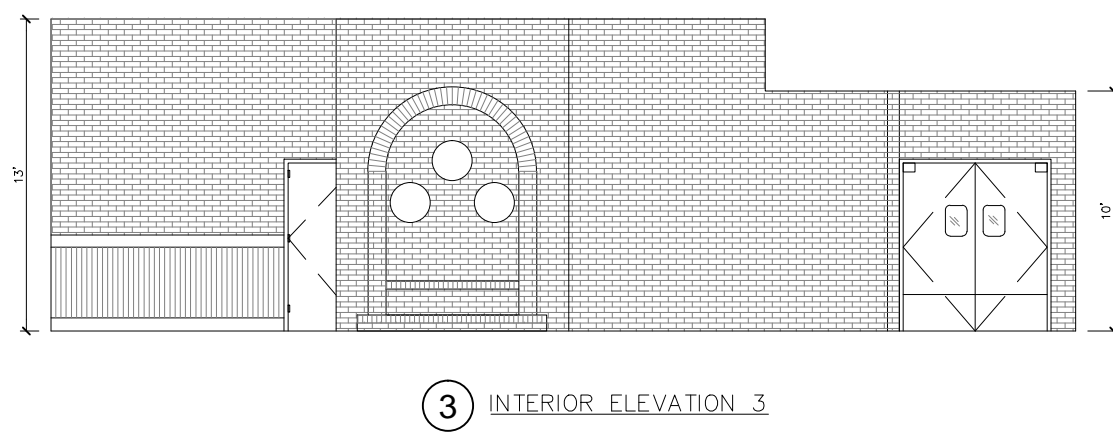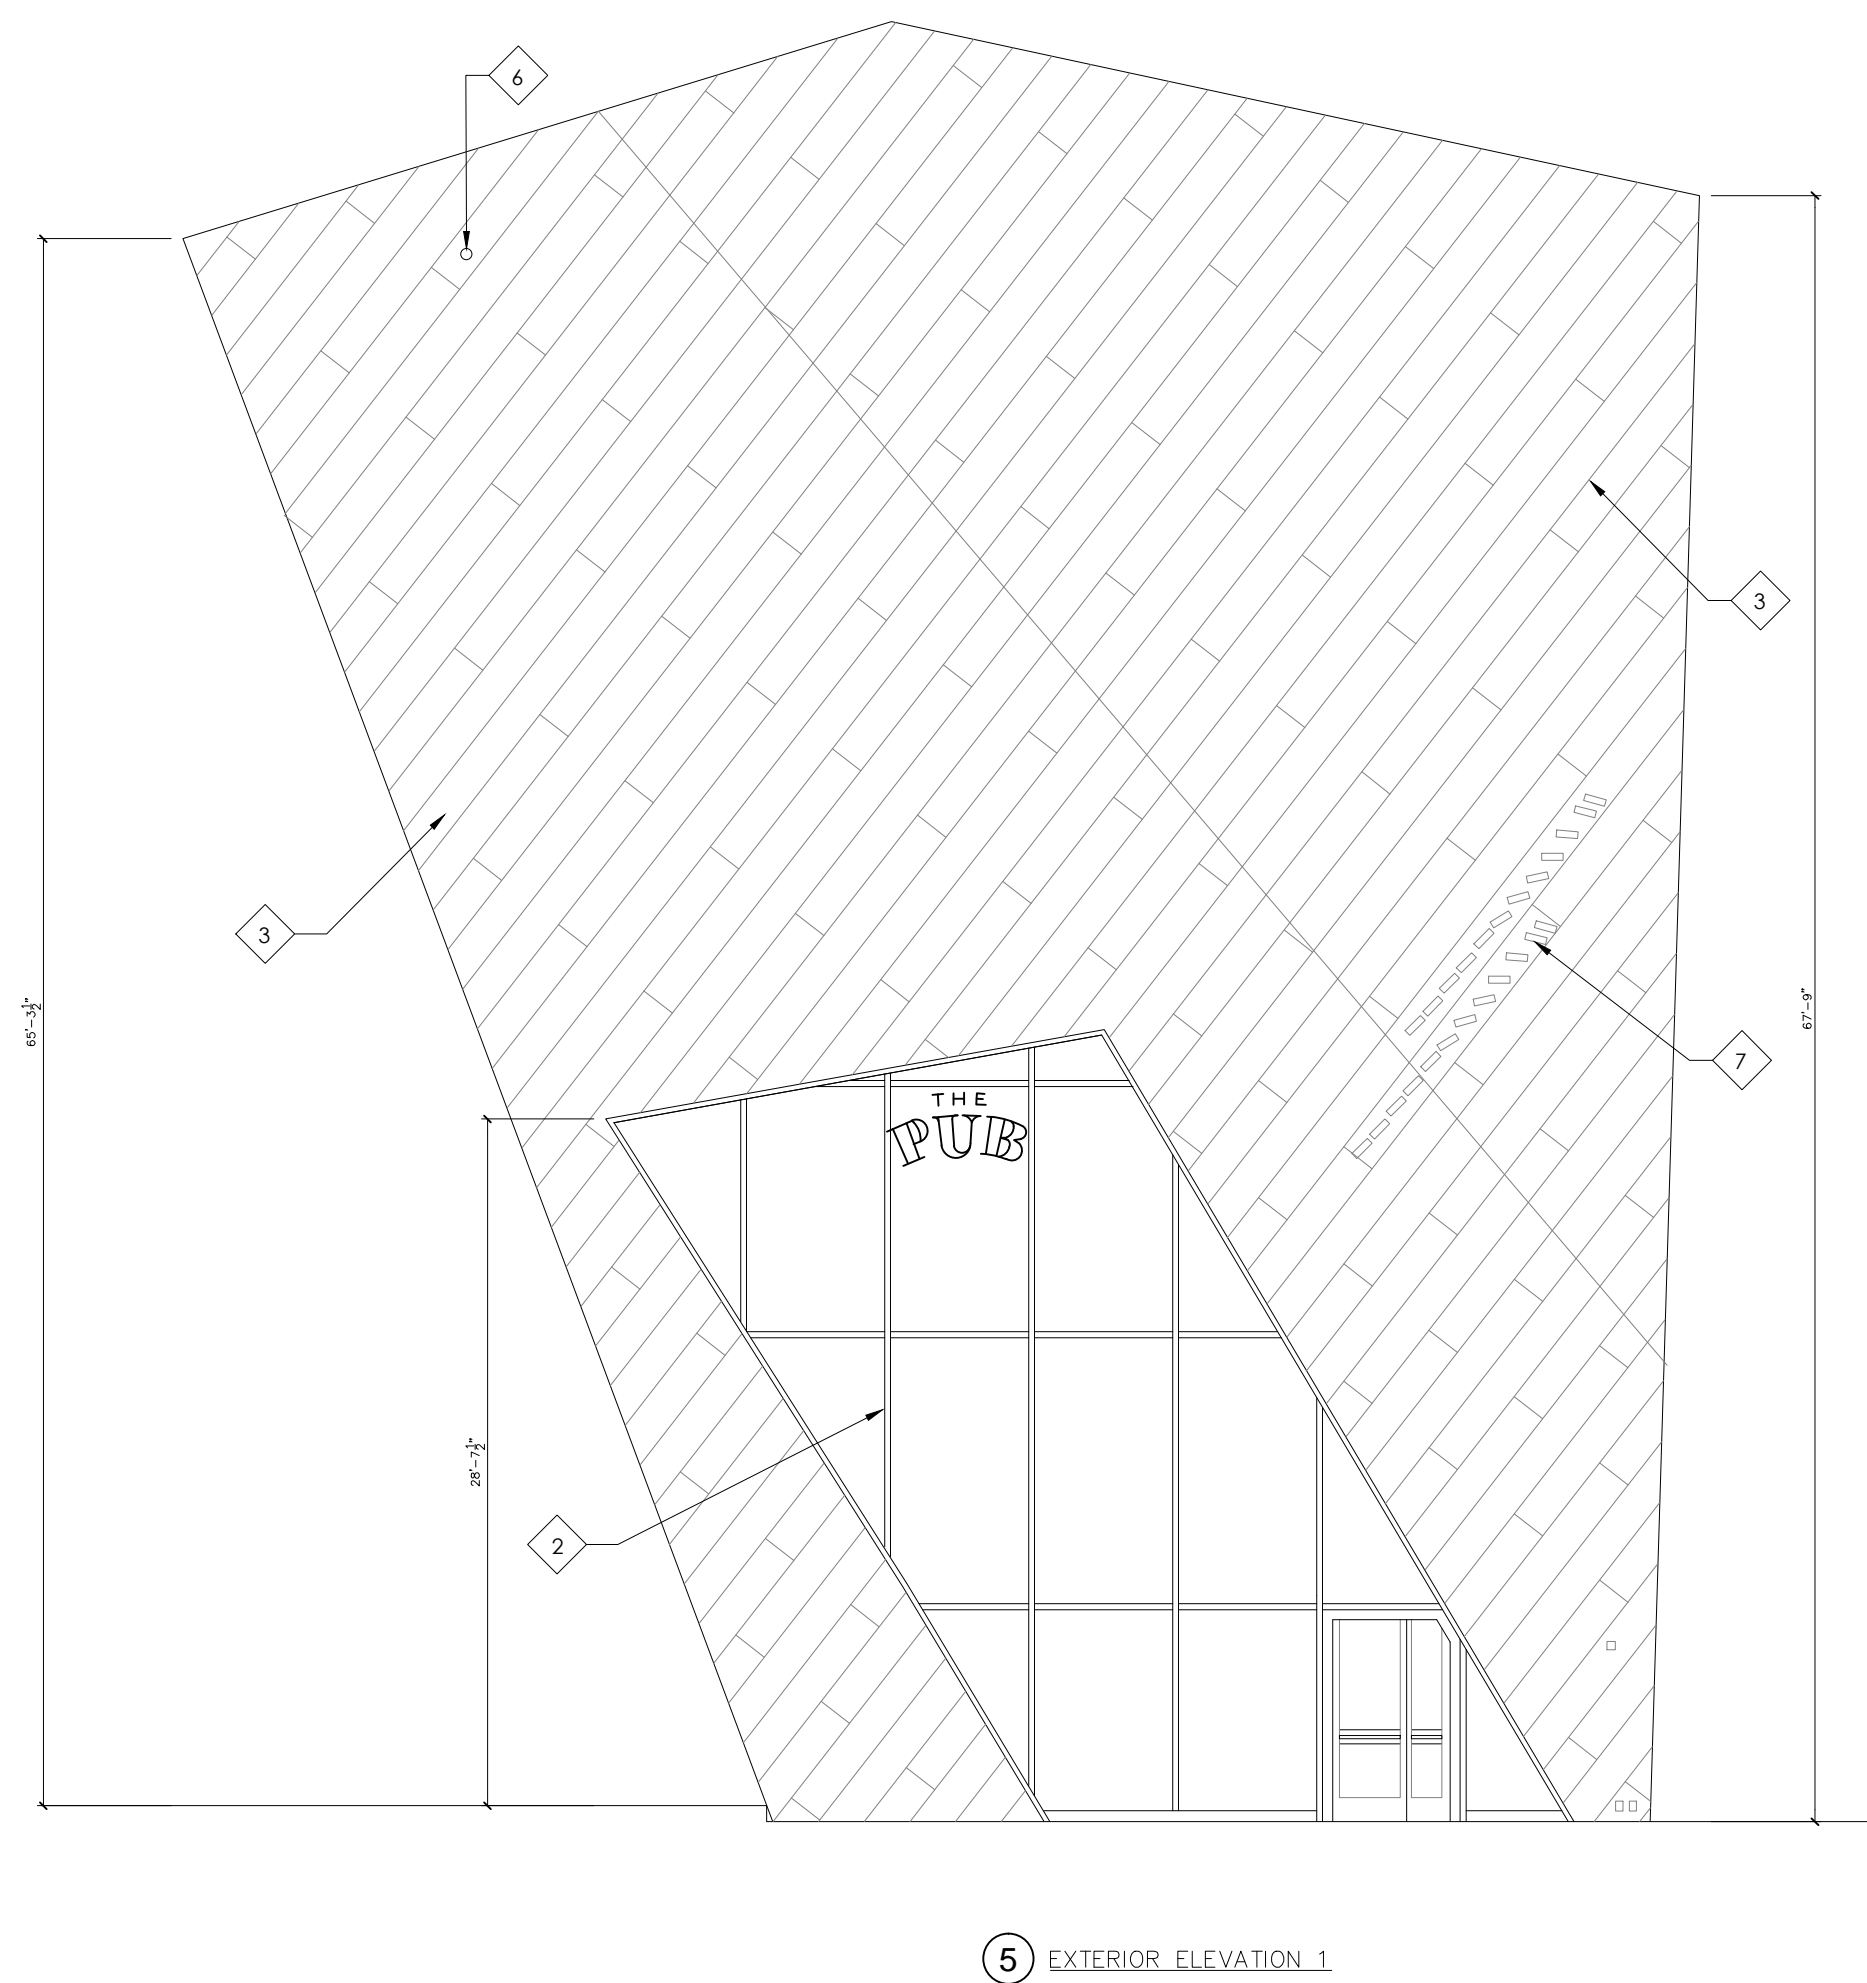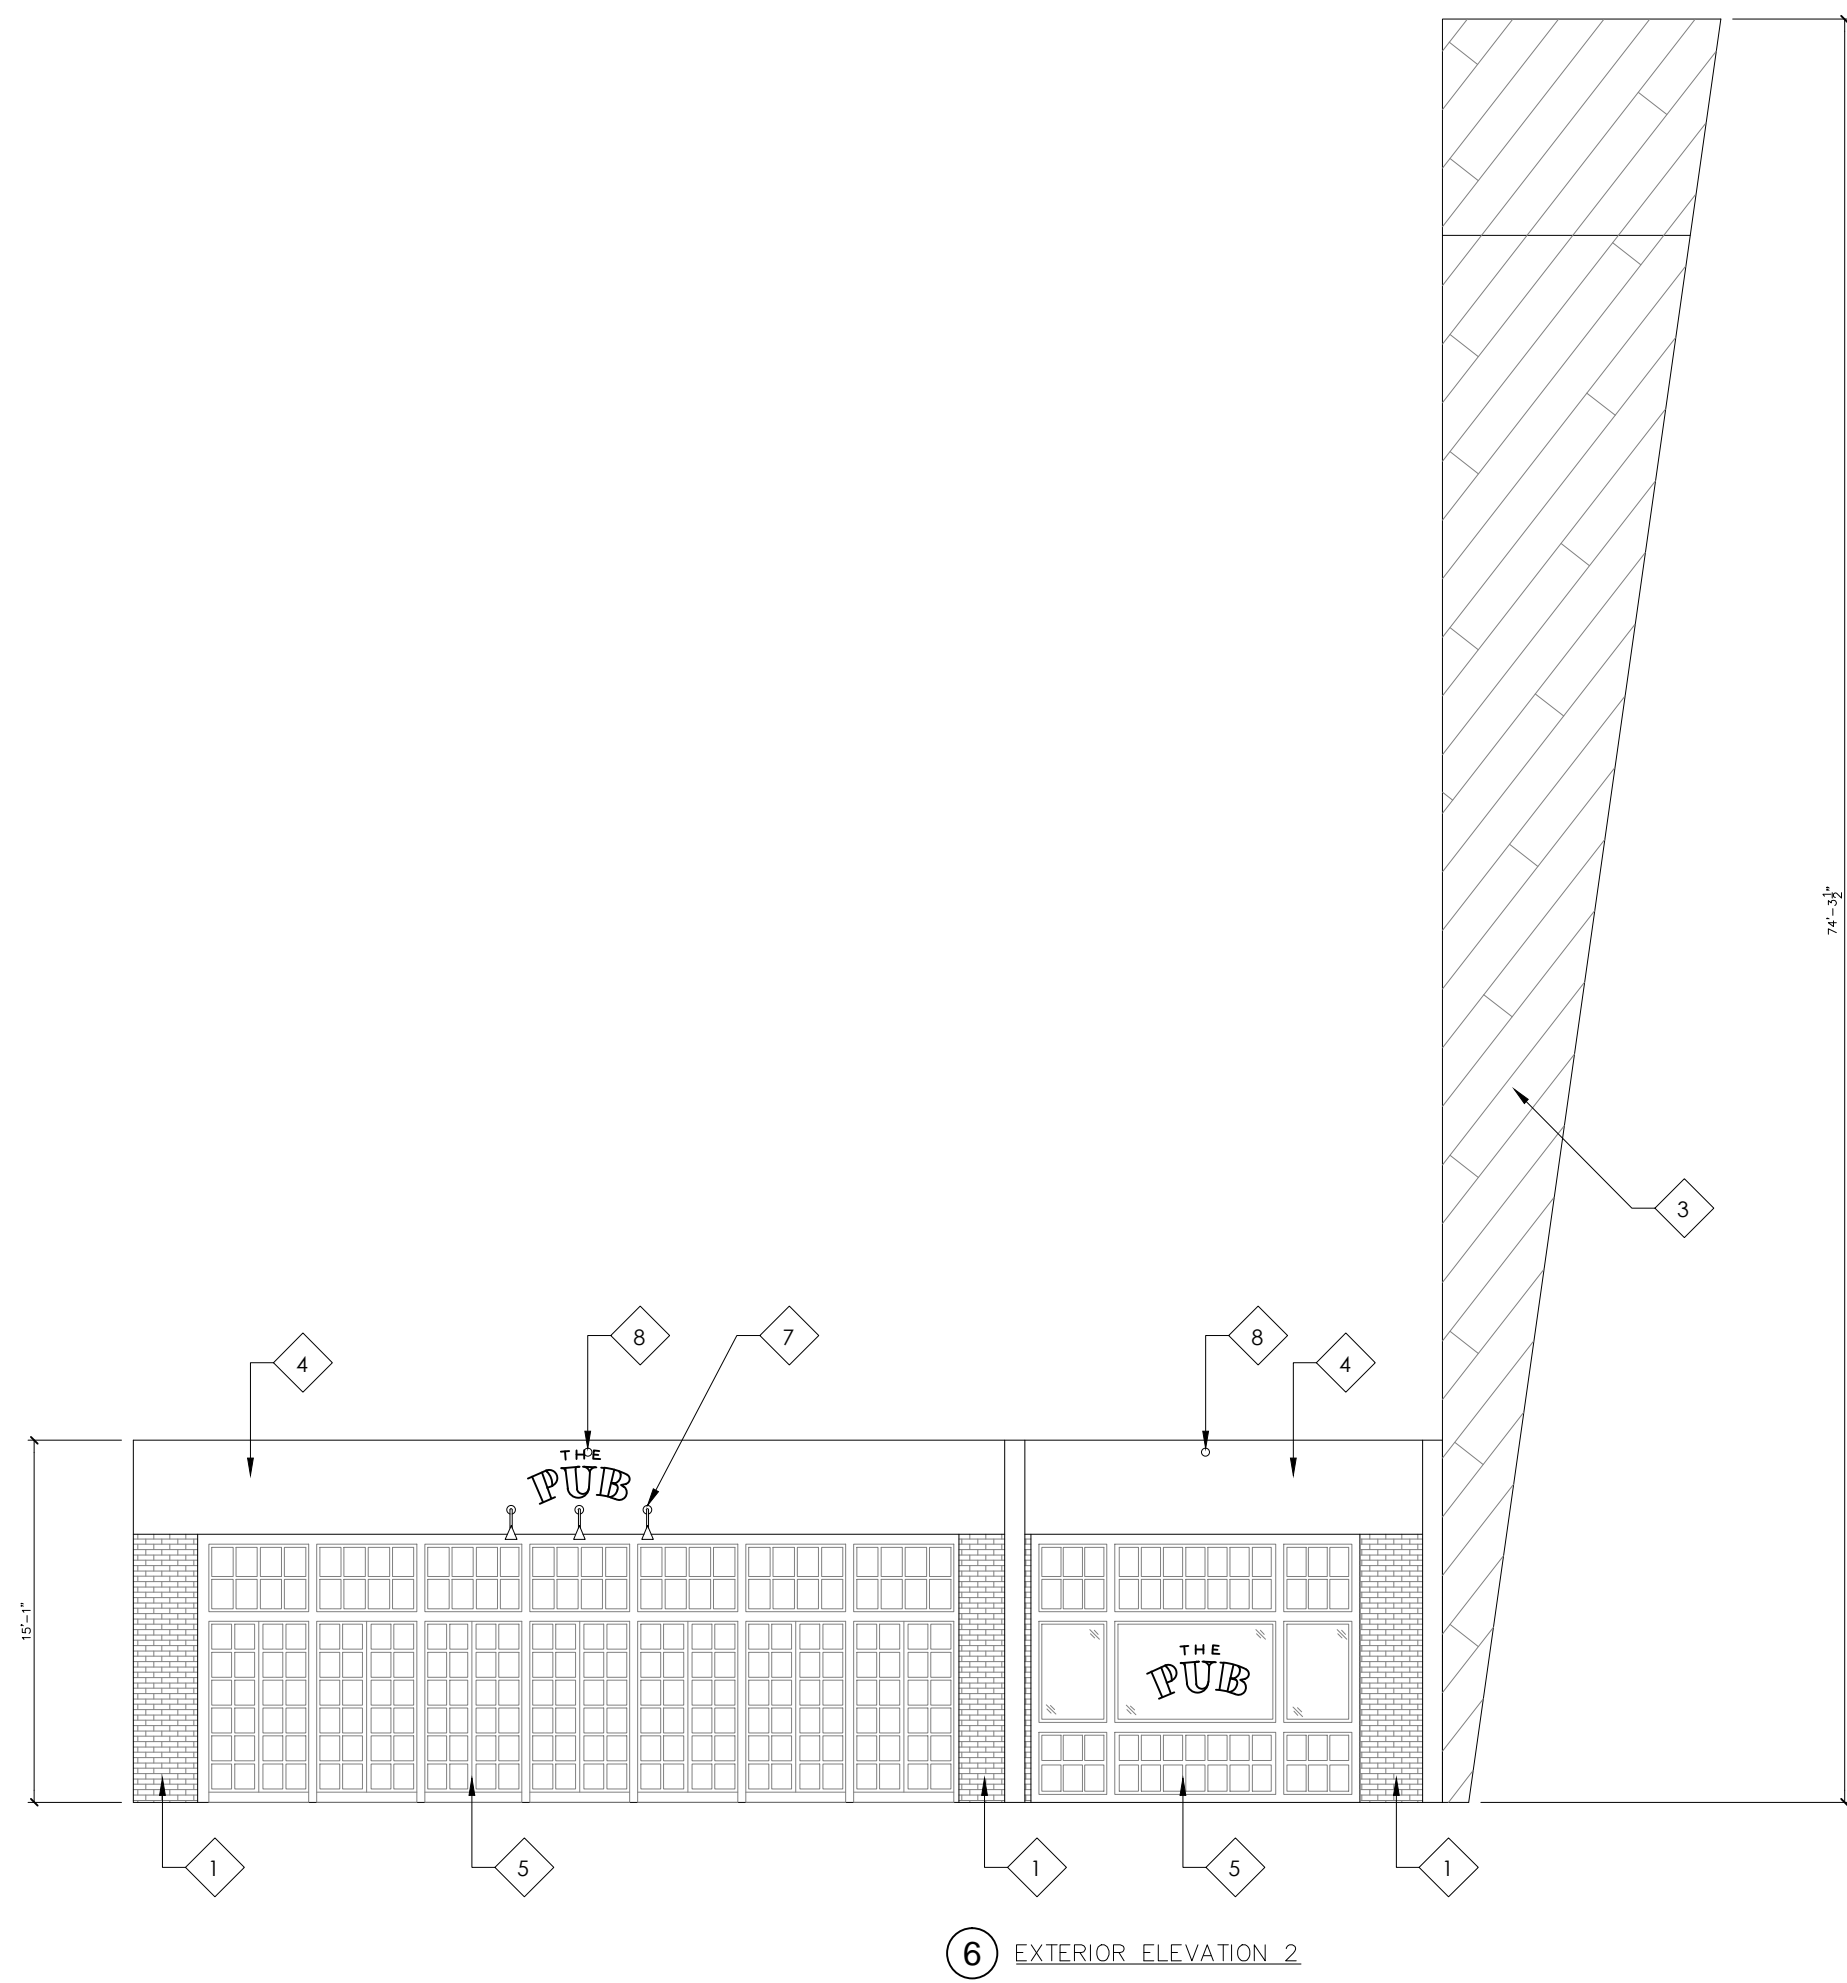

01	100% SUBMISSION	SEE COVER SHEET
NO.	ISSUES REVISIONS	DATE
		SHEET TITLE

ELEVATIONS

HL	PROJECT MANAGER
HL	PROJECT DIRECTOR
	PROJECT NUMBER
1/8"=1'-0"	SCALE
MM	DRAWN BY
	SHEET NUMBER