

AS-BUILT DOCUMENTATION

LAVA BEDS NATIONAL MONUMENT




DRAWING INDEX

- C-1 COVER SHEET | DRAWING INDEX
- SL SYMBOLS LEGEND
- AB-1 BUILDING 70 FLOOR PLAN & RCP
- AB-2 BUILDING 71 FLOOR PLAN & RCP
- AB-3 BUILDING 77 FLOOR PLAN & RCP
- AB-4 ROOF PLANS
- AB-5 EXTERIOR ELEVATIONS
- AB-6 BUILDING SECTIONS

Scope of Work:

- FLOOR PLANS
- 4 EXTERIOR ELEVATIONS
- (MEP) LOCATE VISIBLE MECHANICAL, ELECTRICAL AND PLUMBING ON WALLS AND FLOOR.
- (RCP WITH MEP) REFLECTED CEILING PLAN (HEIGHTS, TRANSITIONS AND VISIBLE MEP ITEMS)
- ONE TRANSVERSE AND ONE LONGITUDINAL BUILDING SECTION OF OBSERVABLE ELEMENTS
- ROOF PLAN

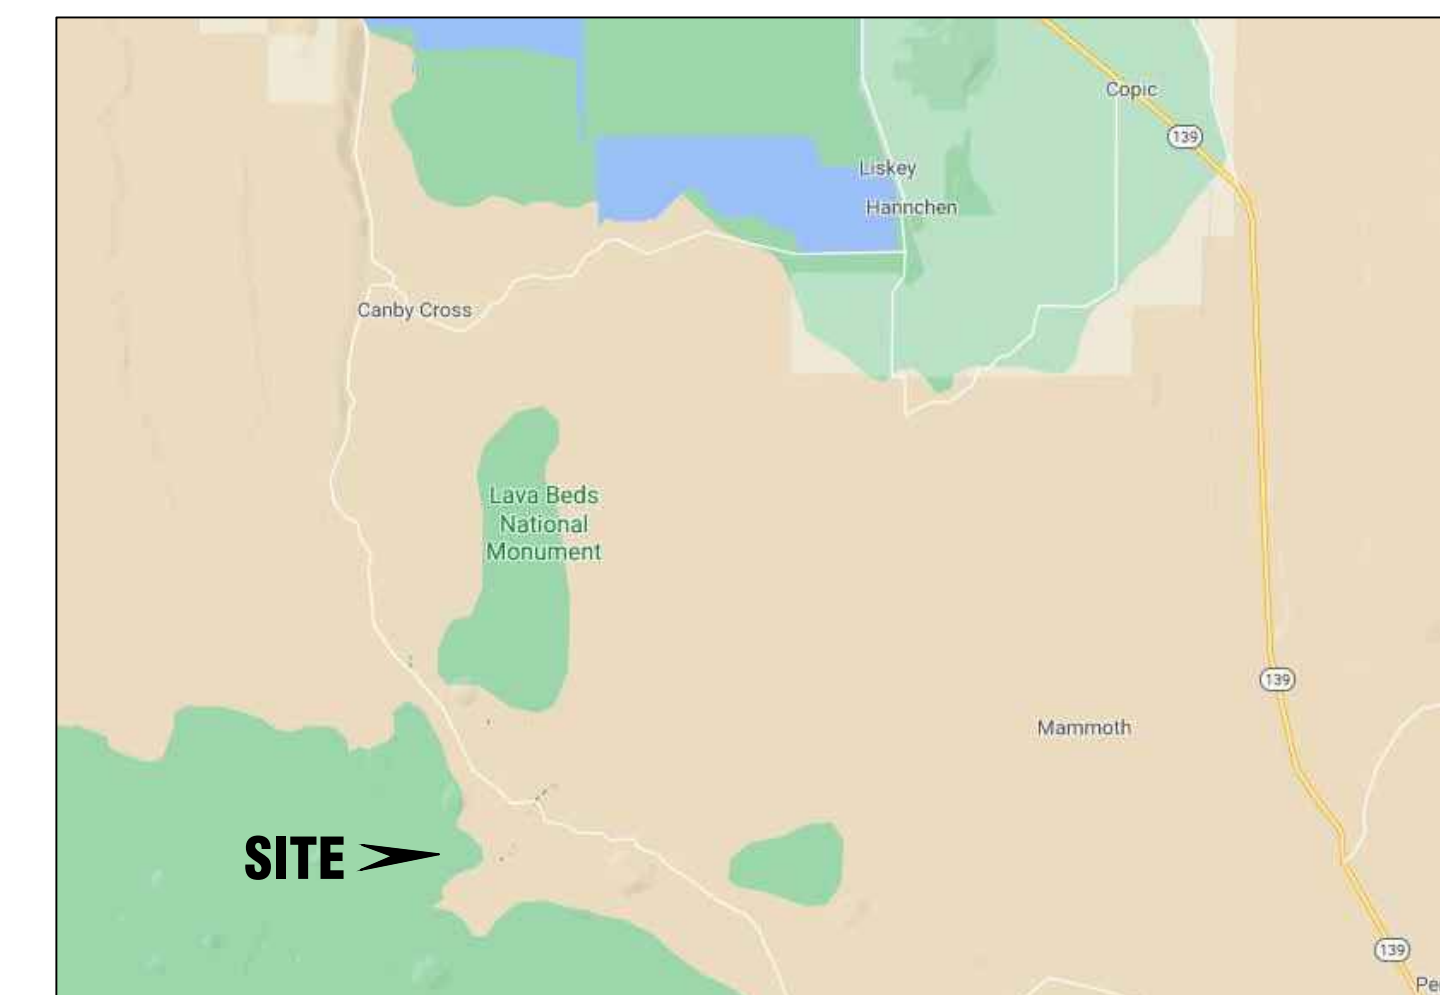

VICINITY MAP
NTS

AREA DATA	
BLDG 70 OPS CENTER	
MAIN FLOOR	1,853 S.F. ±
UPSTAIRS STORAGE	353 S.F. ±
BLDG 71 MAINTENANCE	
MAIN FLOOR	3,710 S.F. ±
MEZZANINE	947 S.F. ±
BLDG 77 WOOD STORAGE	
MAIN FLOOR	1,440 S.F. ±
MEZZANINE	255 S.F. ±
TOTAL	8,558 S.F. ±



ARCHITECTURAL AS BUILT

MAINTENANCE FACILITY

100% SUBMITTAL

NO.	ISSUES REVISIONS	DATE

COVER SHEET

HL PROJECT MANAGER

HL PROJECT DIRECTOR

? PROJECT NUMBER

SCALE

MM DRAWN BY

SHEET NUMBER

C-1

SYMBOLS LEGEND

RCP

	EXHAUST VENT		TRACK LIGHT OR VANITY LIGHT
	CEILING MOUNTED LIGHT FIXTURE		WALL-MOUNTED LIGHT FIXTURE
	CEILING MOUNTED DIRECTIONAL LIGHT		EMERGENCY EXIT SIGN
	RECESSED CAN LIGHT		EMERGENCY EXIT LIGHT
	EYEBALL OR SMALL CAN LIGHT		EMERGENCY EXIT LIGHT W/ SIGN
	PENDANT LIGHT		LIGHTED STAIR SIGN
	INDIVIDUAL FLUOR. LAY-IN FIXTURE 4 BULB		FLOOD LIGHT
	INDIVIDUAL FLUOR. HANGING FIXTURE 2 BULB		PHOTO CELL
	INDIVIDUAL FLUOR. FLUSH MOUNT FIXTURE 4 BULB		CEILING FAN
	CAMERA		CEILING FAN W/ LIGHT KIT
	MOTION DET.		JUNCTION BOX
	SUPPLY VENT		
	RETURN VENT		
	SPEAKER		

7-2-6 CEILING HEIGHT AND TRIM 7'-2" ABOVE FLOOR BELOW WITH 6" CROWN MOULDING. NOTE: ALL CEILINGS NOT LABELED ARE PLASTER. CEILINGS SHOWN WITH A GRID ARE LAY IN ACOUSTICAL TILE..

ELECTRIC

	DATA OUTLET
	TELEPHONE JACK
	ELECTRIC SWITCH
	CABLE TELEVISION OUTLET
	DUPLEX RECEPTACLE OUTLET
	SPECIAL PURPOSE CONNECTION OR OUTLET
	QUADRUPLEX RECEPTACLE OUTLET
	FLOOR DUPLEX RECEPTACLE OUTLET
	ELECTRIC PANEL
	ELECTRIC METER
	BUTTON SWITCH
	DISCONNECT SWITCH
	GROUND/FLOOR LIGHT
	KEY PAD

FIRE PROTECTION


	FIRE EXTINGUISHER
	FIRE PULL
	FIRE ALARM (HORN/SRTOBE)
	SMOKE DETECTOR
	SMOKE ALARM SPEAKER
	SPRINKLER HEAD CEILING MOUNT
	SPRINKLER HEAD WALL MOUNT

MEP


	THERMOSTAT
	FLOOR DRAIN
	VALVE
	HOSE BIB
	WATER SUPPLY
	SUSPENDED GAS HEATER

MISC


	BOLLARD
	SPOT ELEVATION

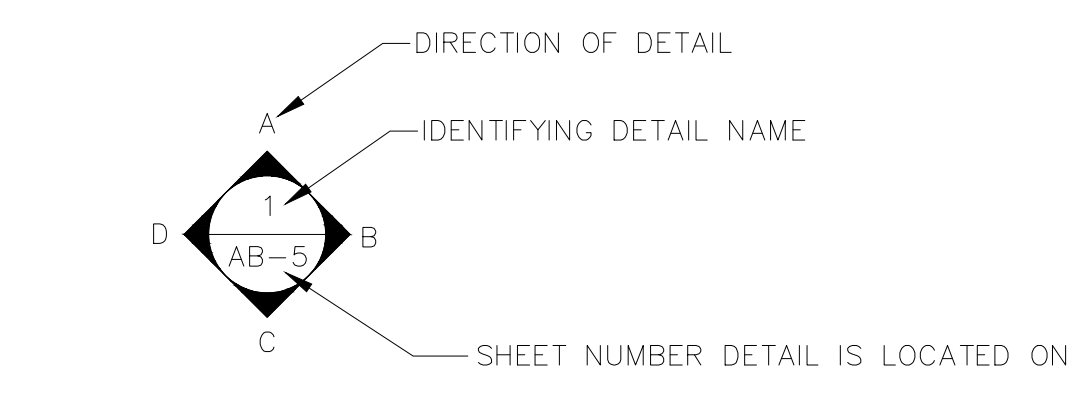

ELEVATIONS

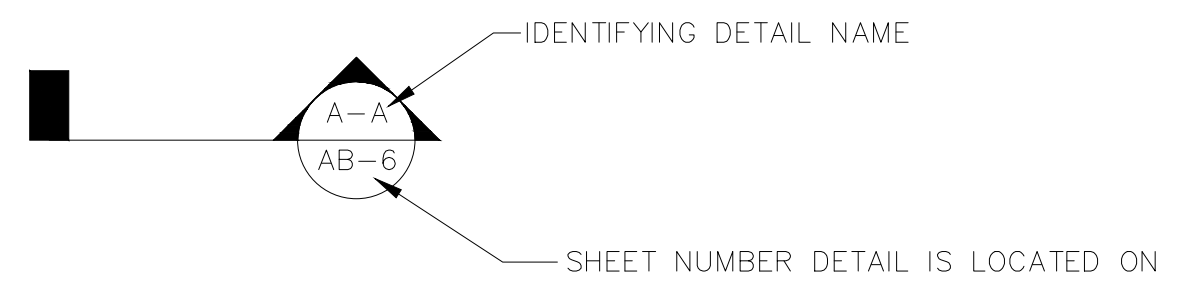

BUILDING SECTION

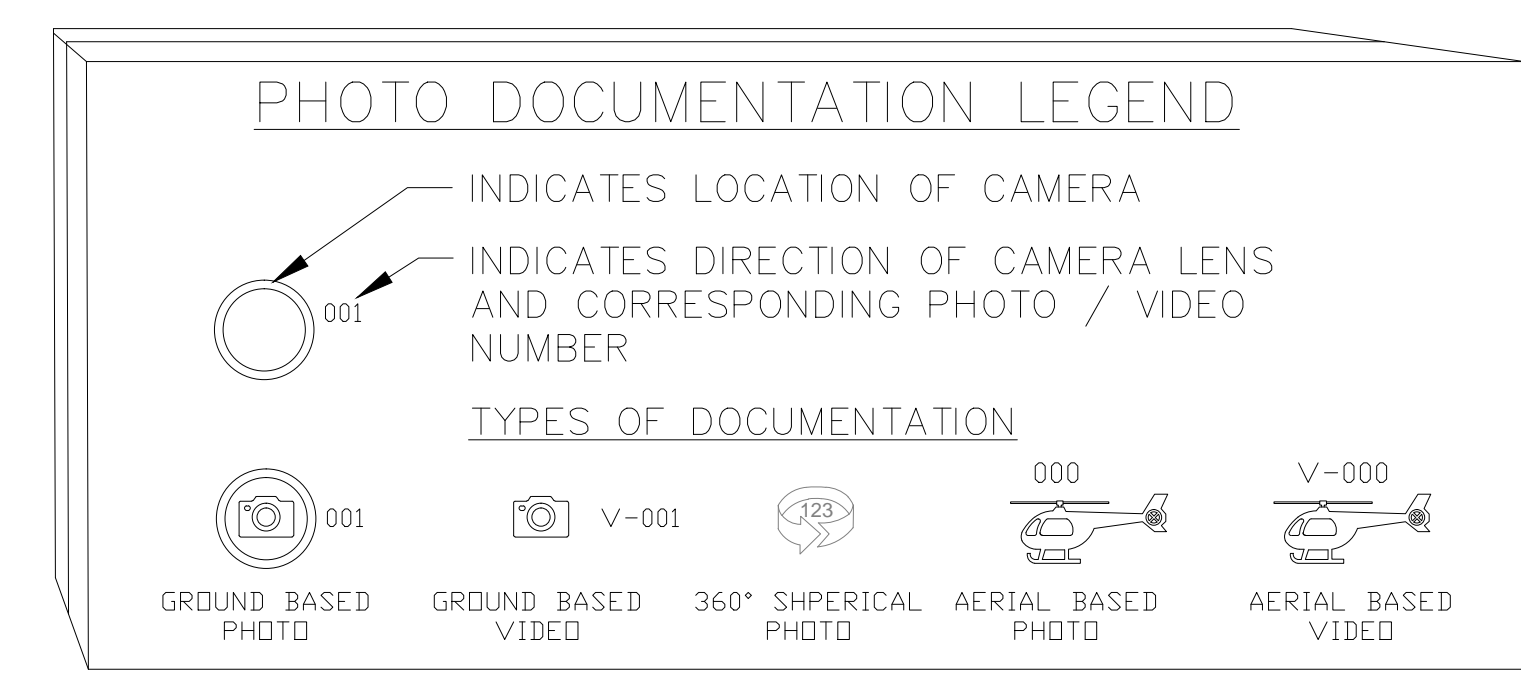

ARCHITECTURAL AS BUILT
MAINTENANCE FACILITY

NO.	ISSUES / REVISIONS	DATE
HL		PROJECT MANAGER
HL		PROJECT DIRECTOR
?		PROJECT NUMBER
NOT TO SCALE		SCALE
MM		DRAWN BY
		SHEET NUMBER


SL

NO.	ISSUES REVISIONS	DATE


SHEET TITLE

BUILDING 70 FLOORPLAN AND RCP


HL	PROJECT MANAGER
HL	PROJECT DIRECTOR
?	PROJECT NUMBER
3/16"=1'-0"	SCALE
MM	DRAWN BY
	SHEET NUMBER

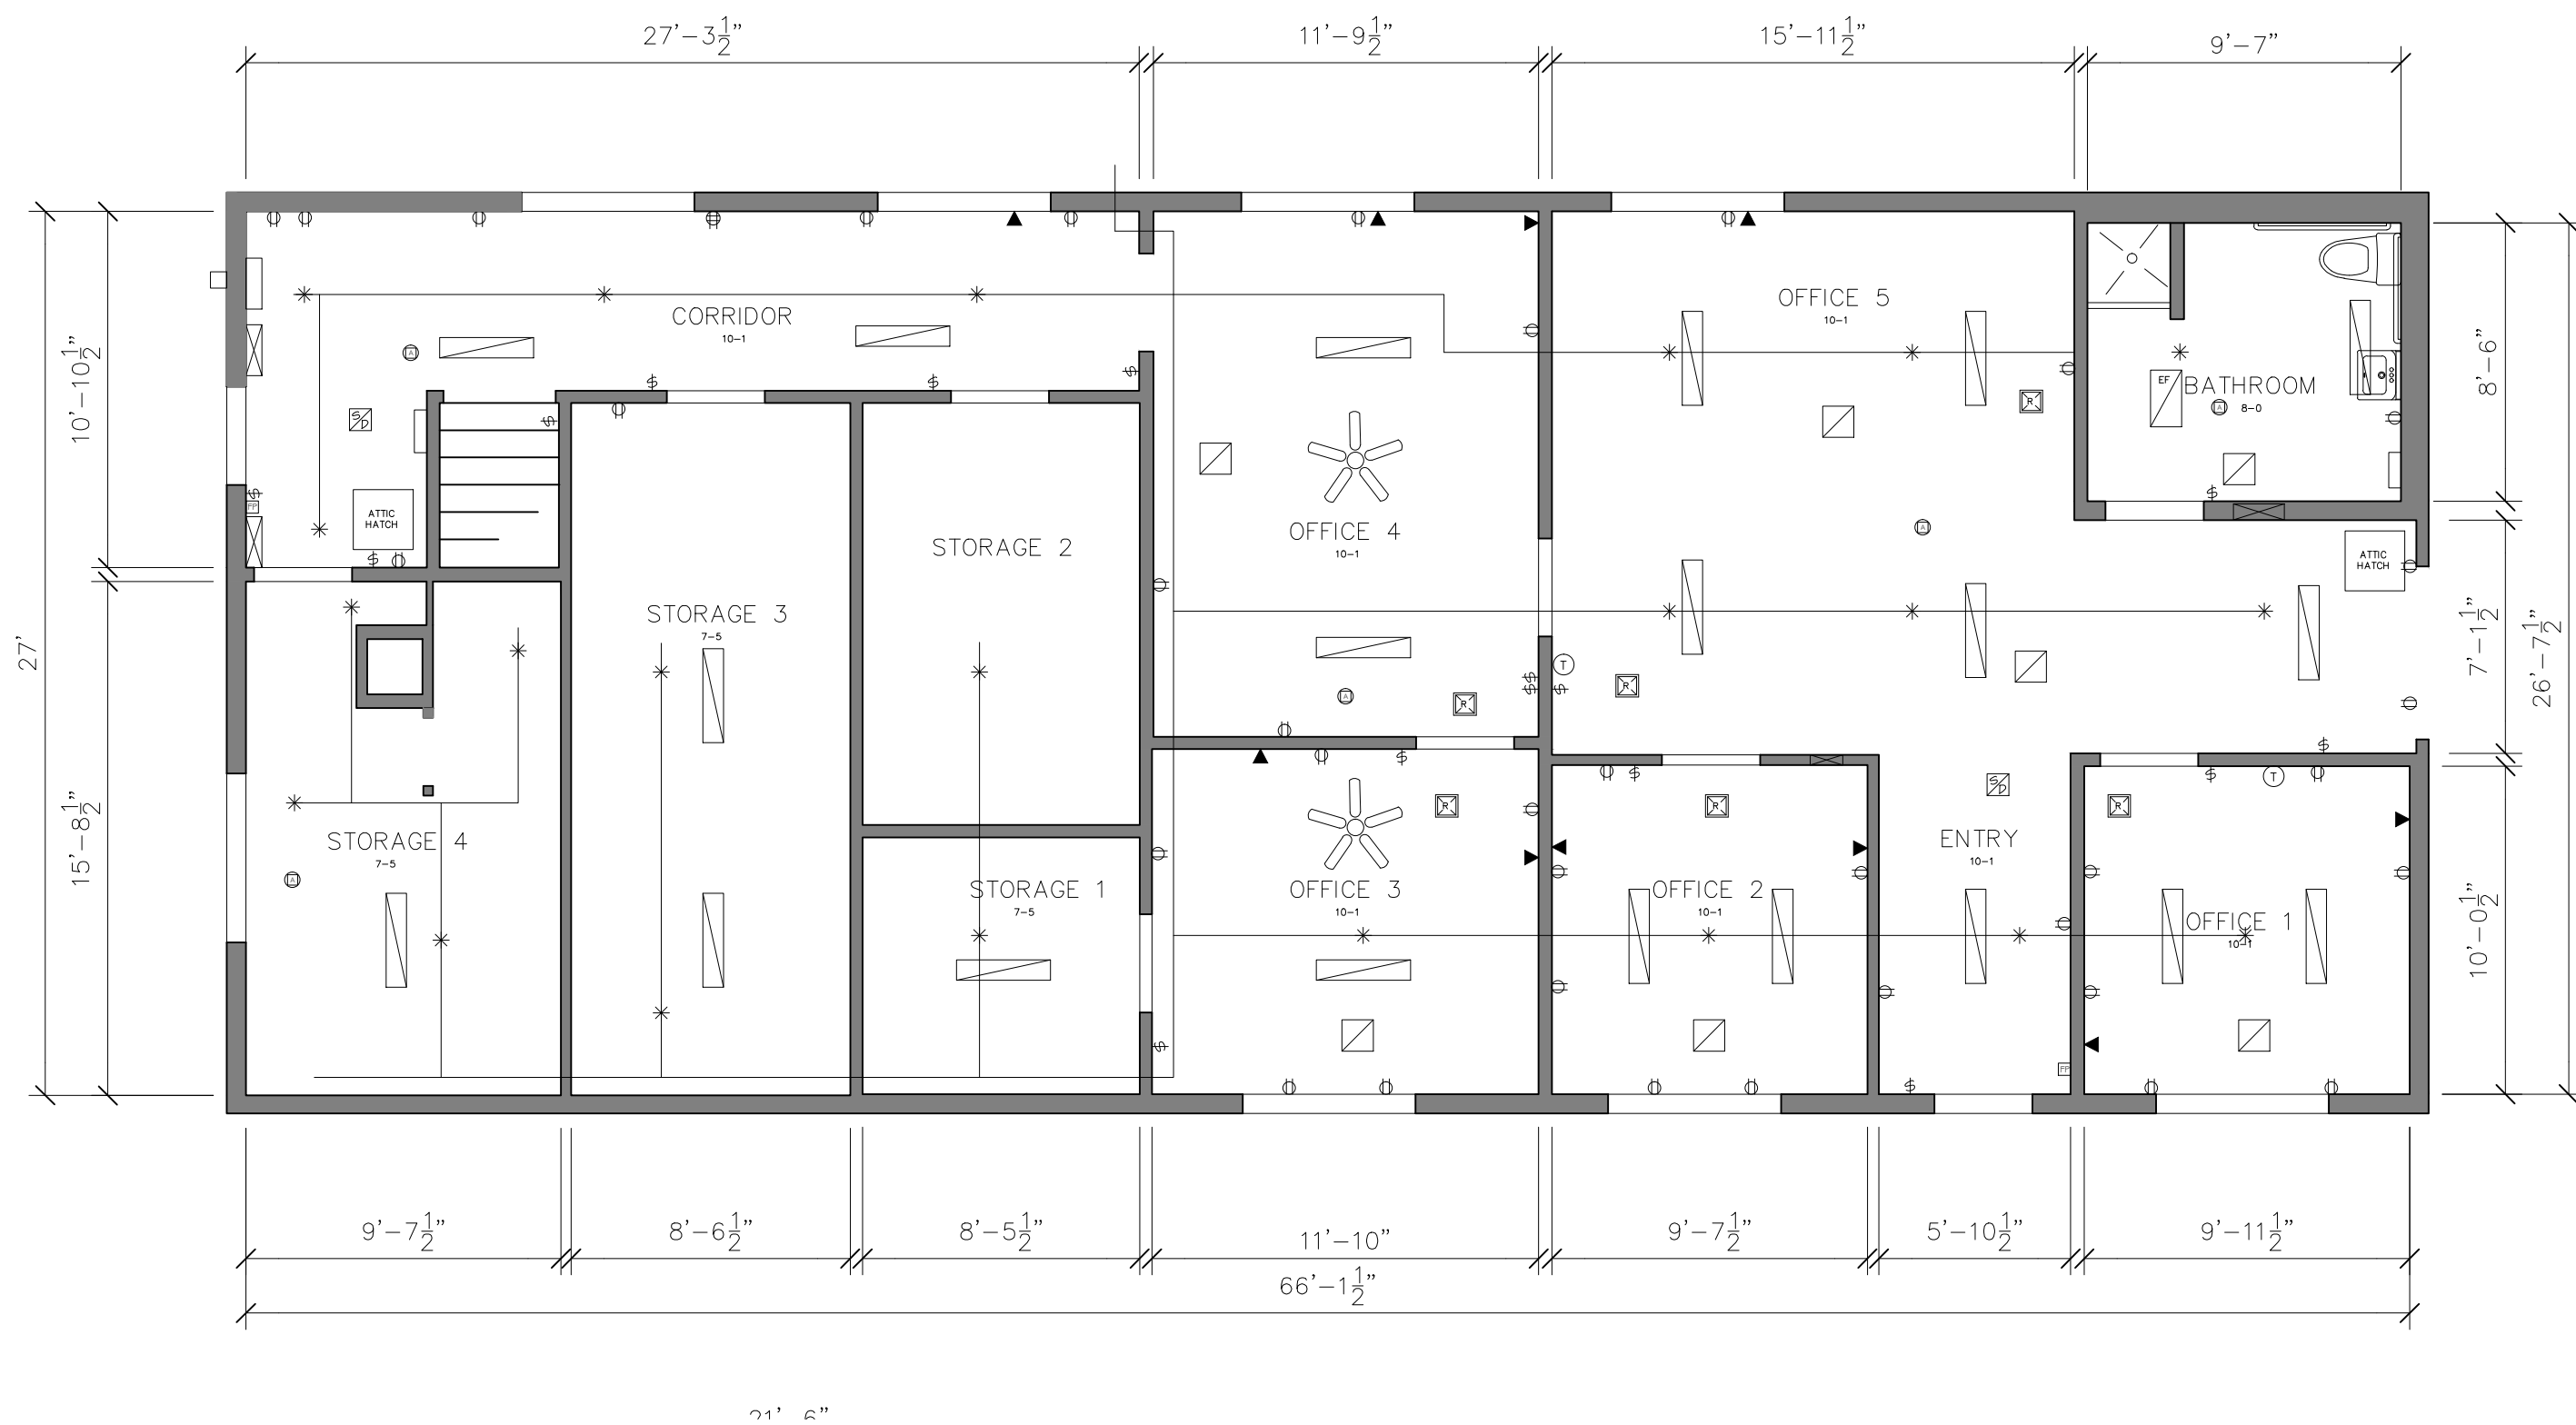


FIRST FLOOR RCP - BUILDING 70 **3**

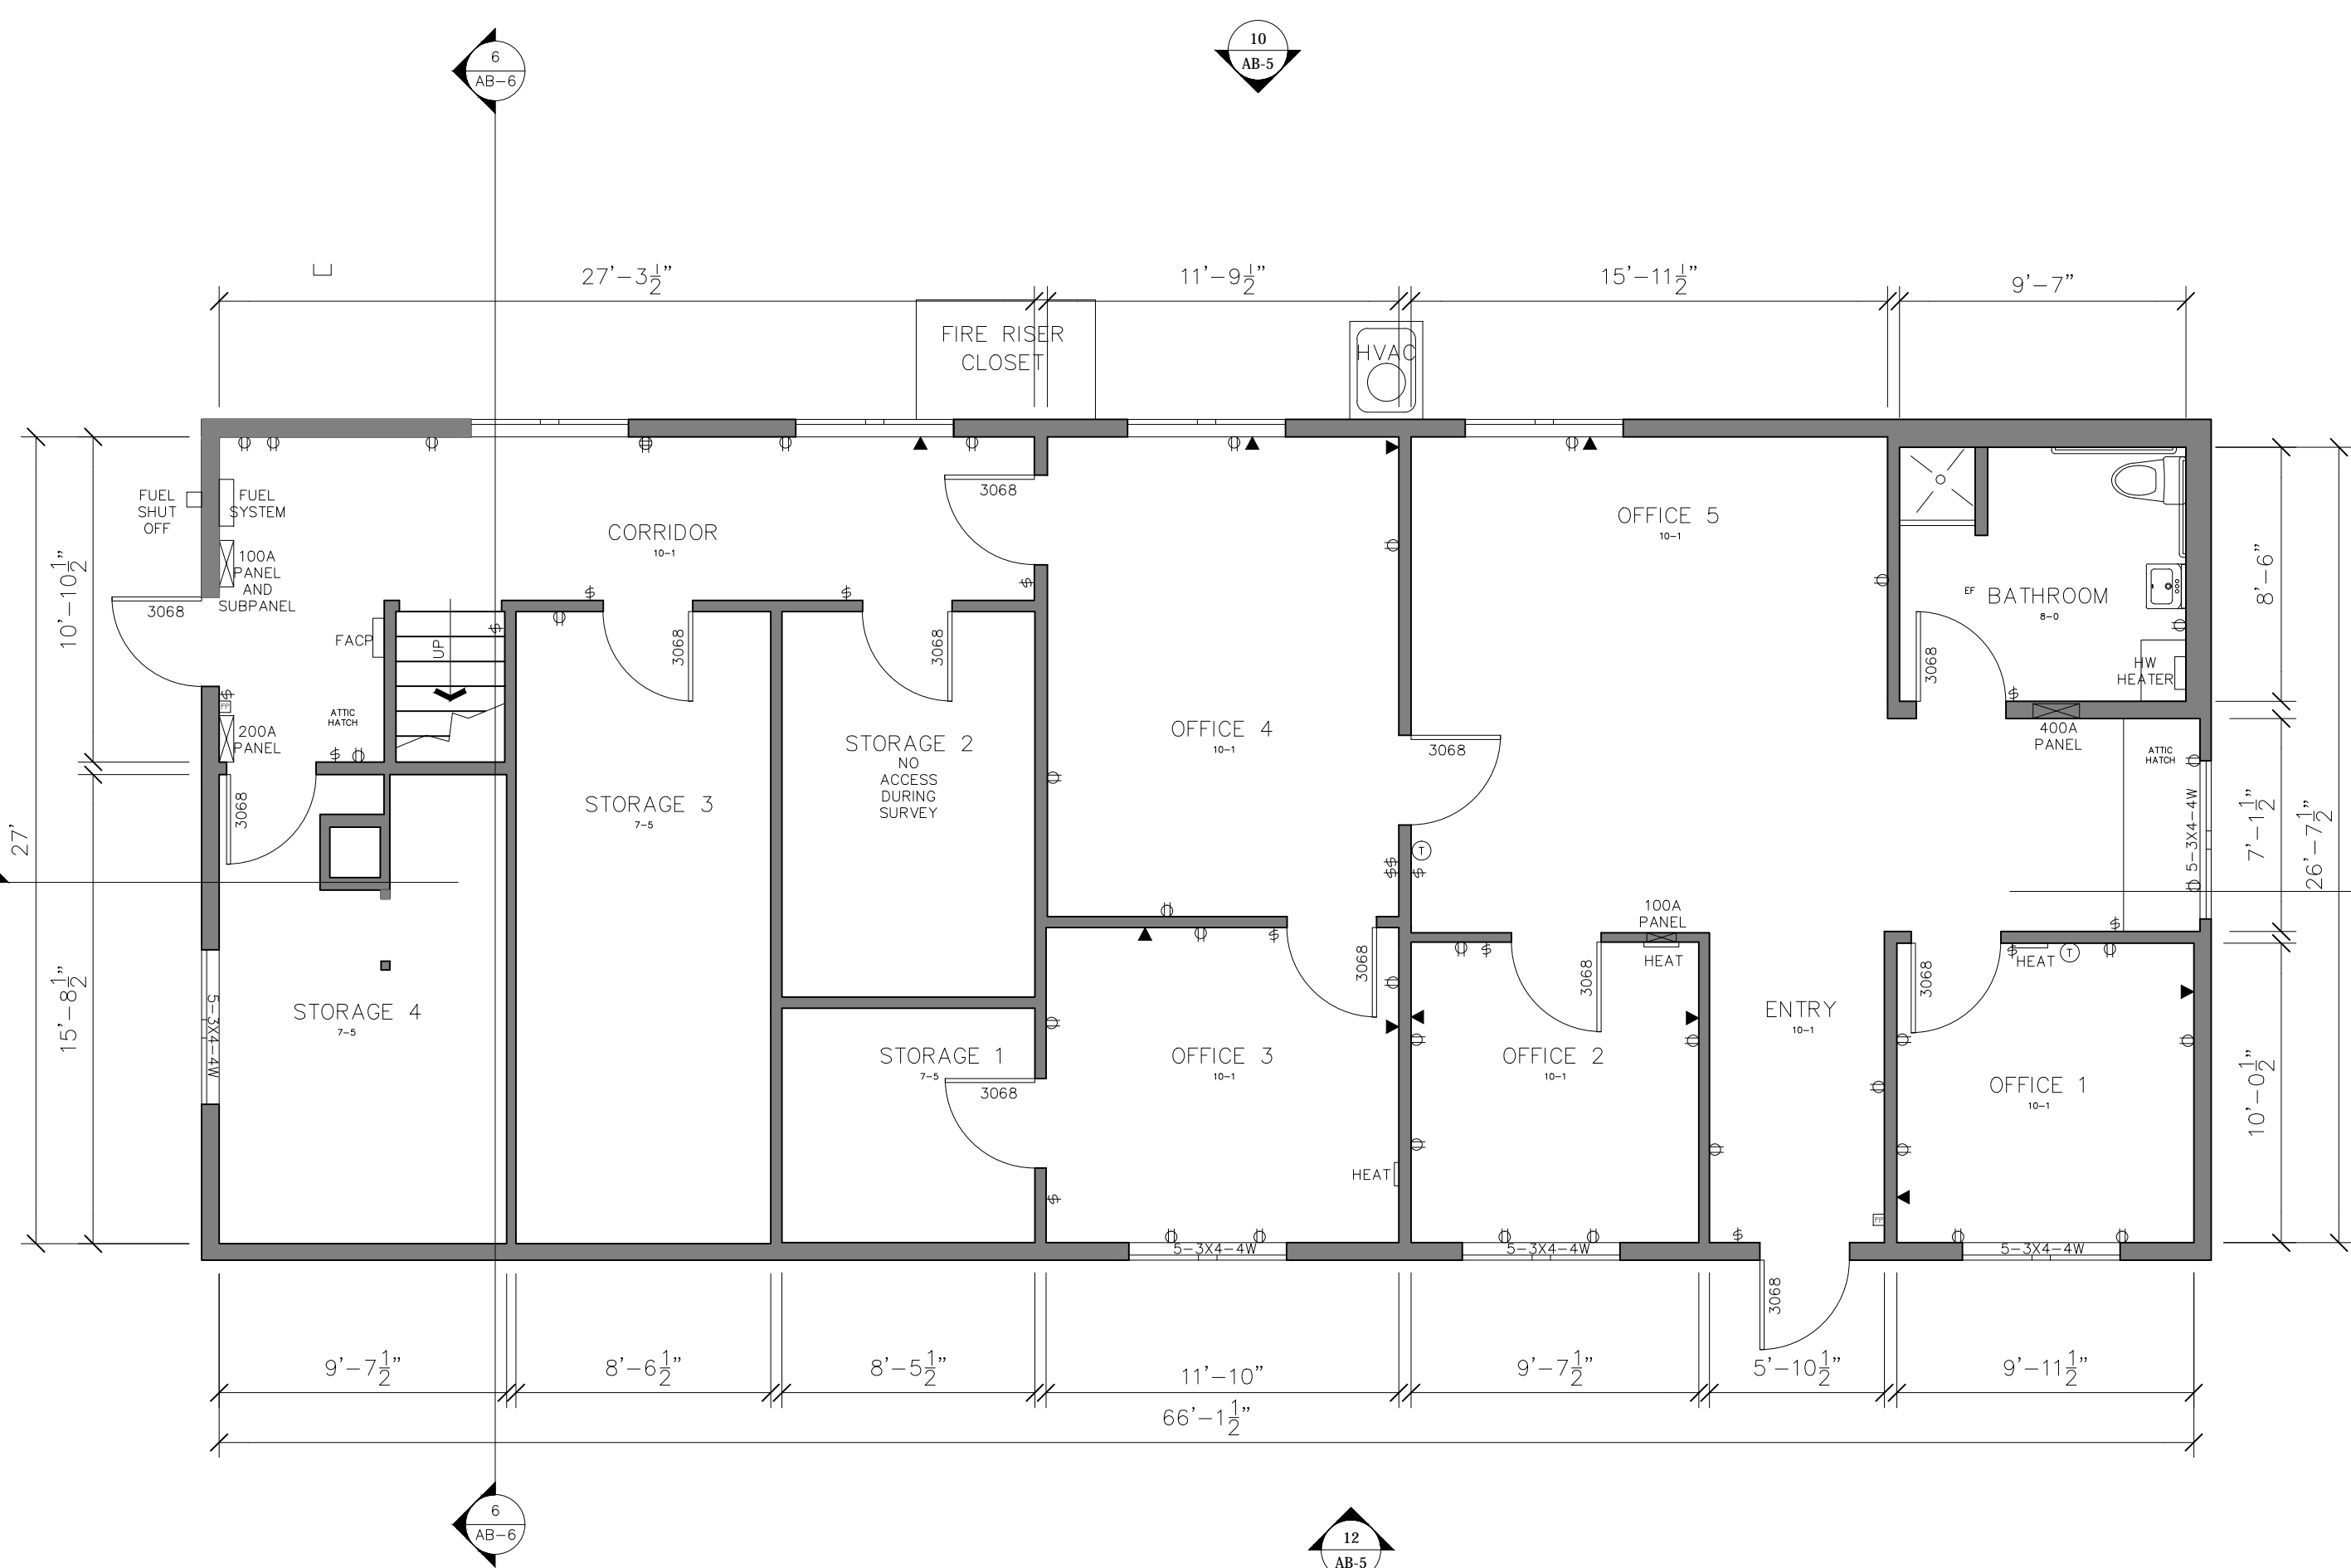


FIRST FLOOR - BUILDING 70 **1**

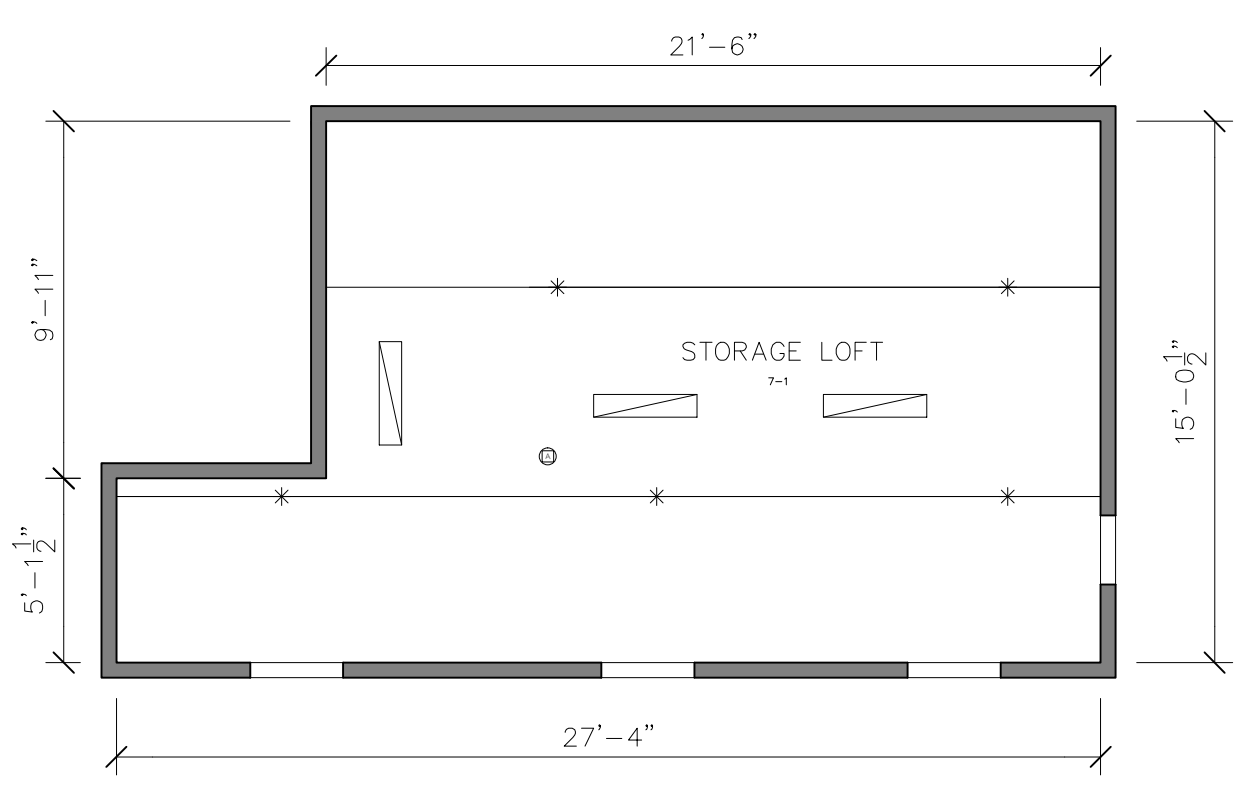


SECONDFLOOR RCP - BUILDING 70 **4**

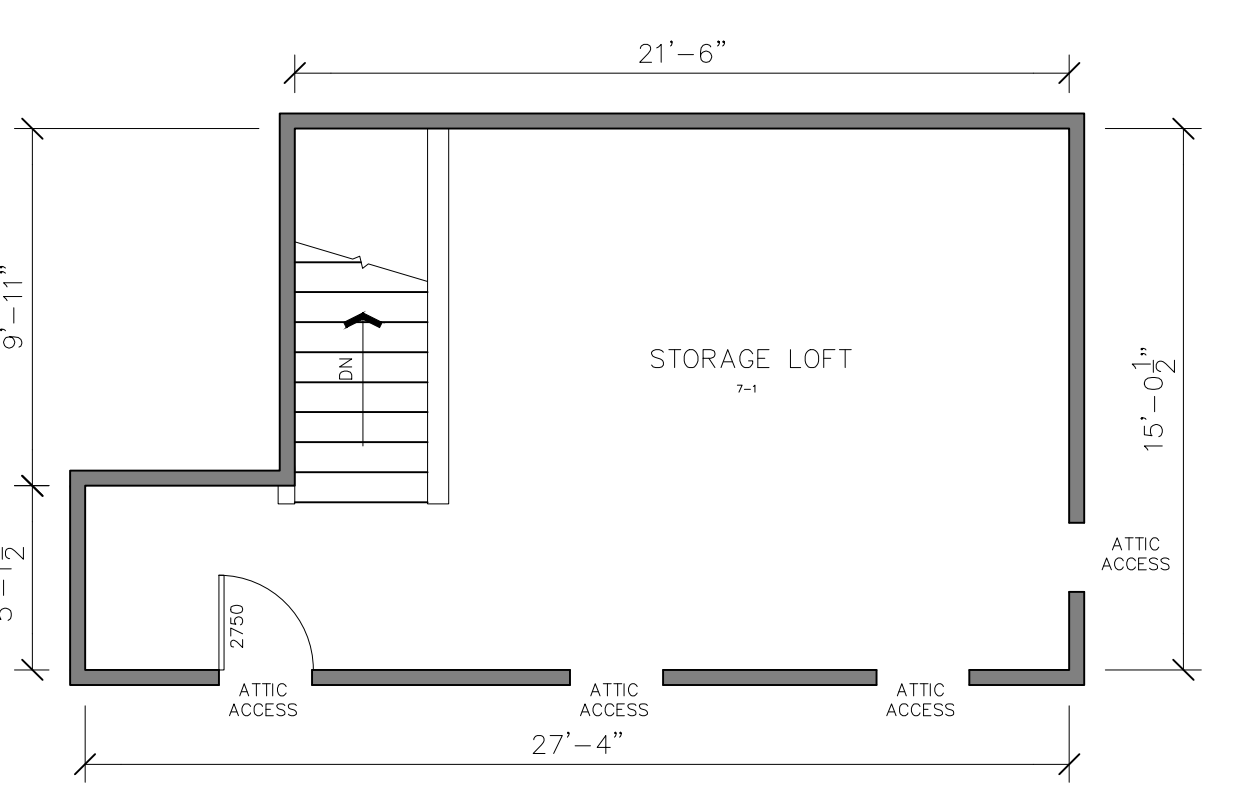

SECOND FLOOR - BUILDING 70 **2**

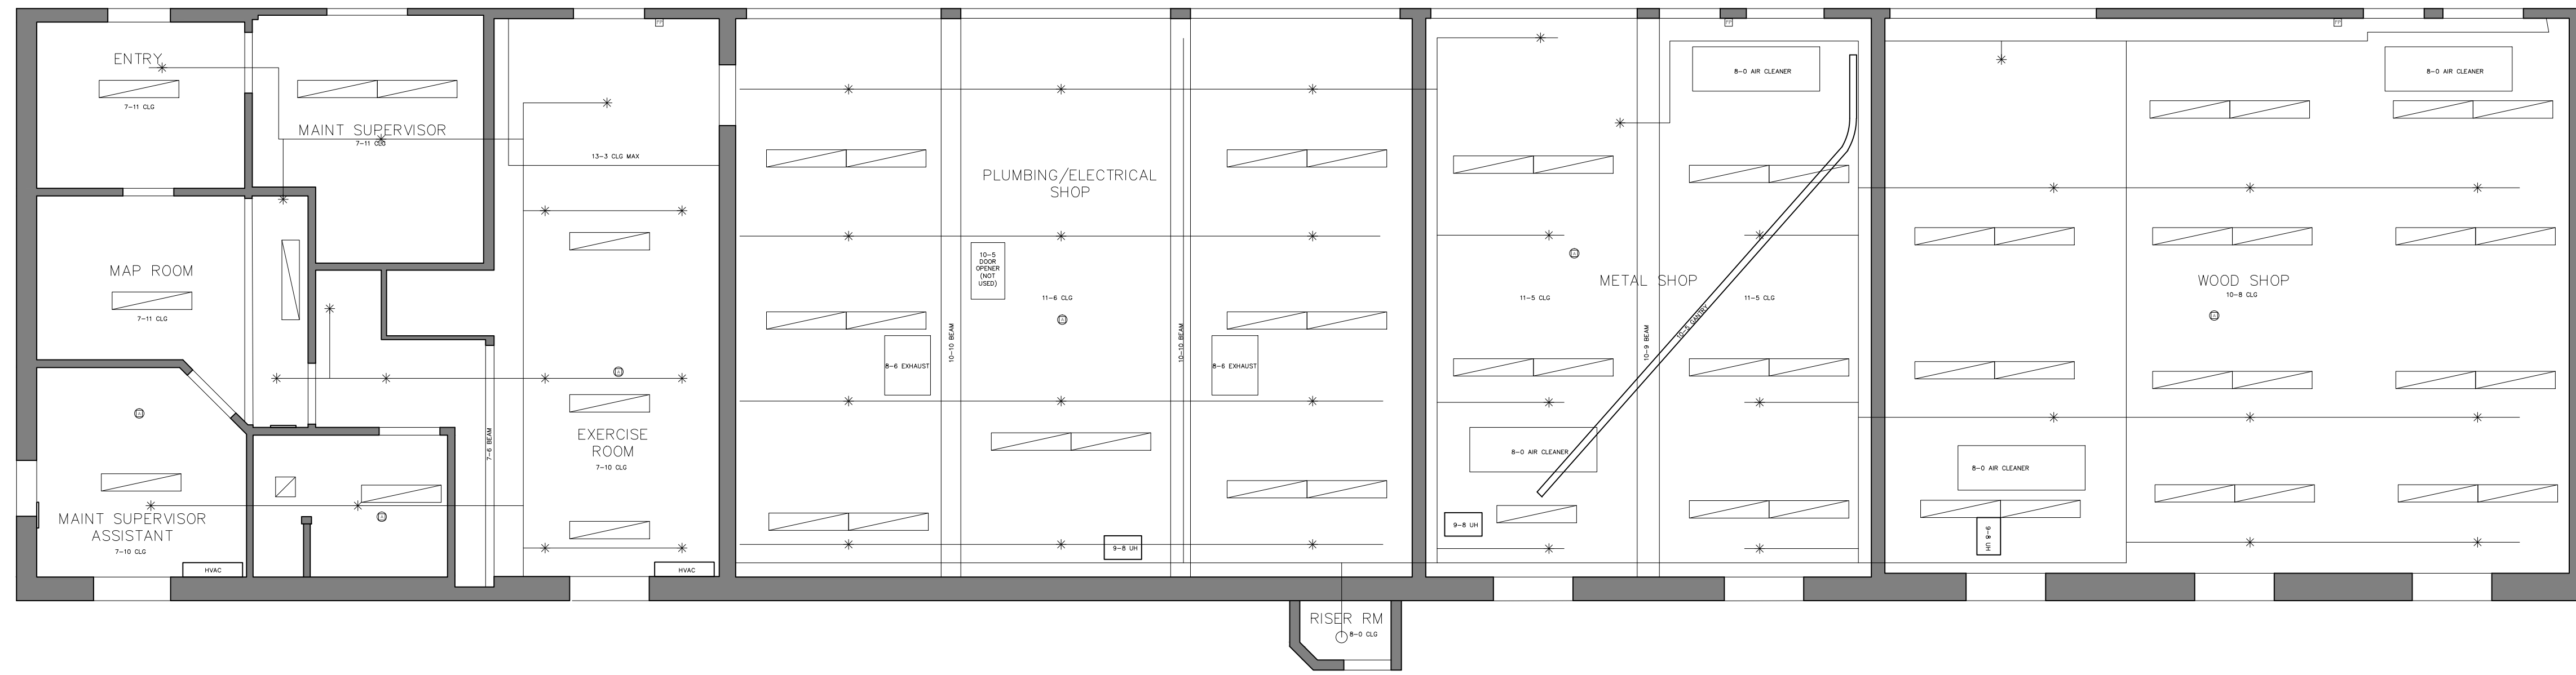

FIRST FLOOR RCP - BUILDING 71 **2**

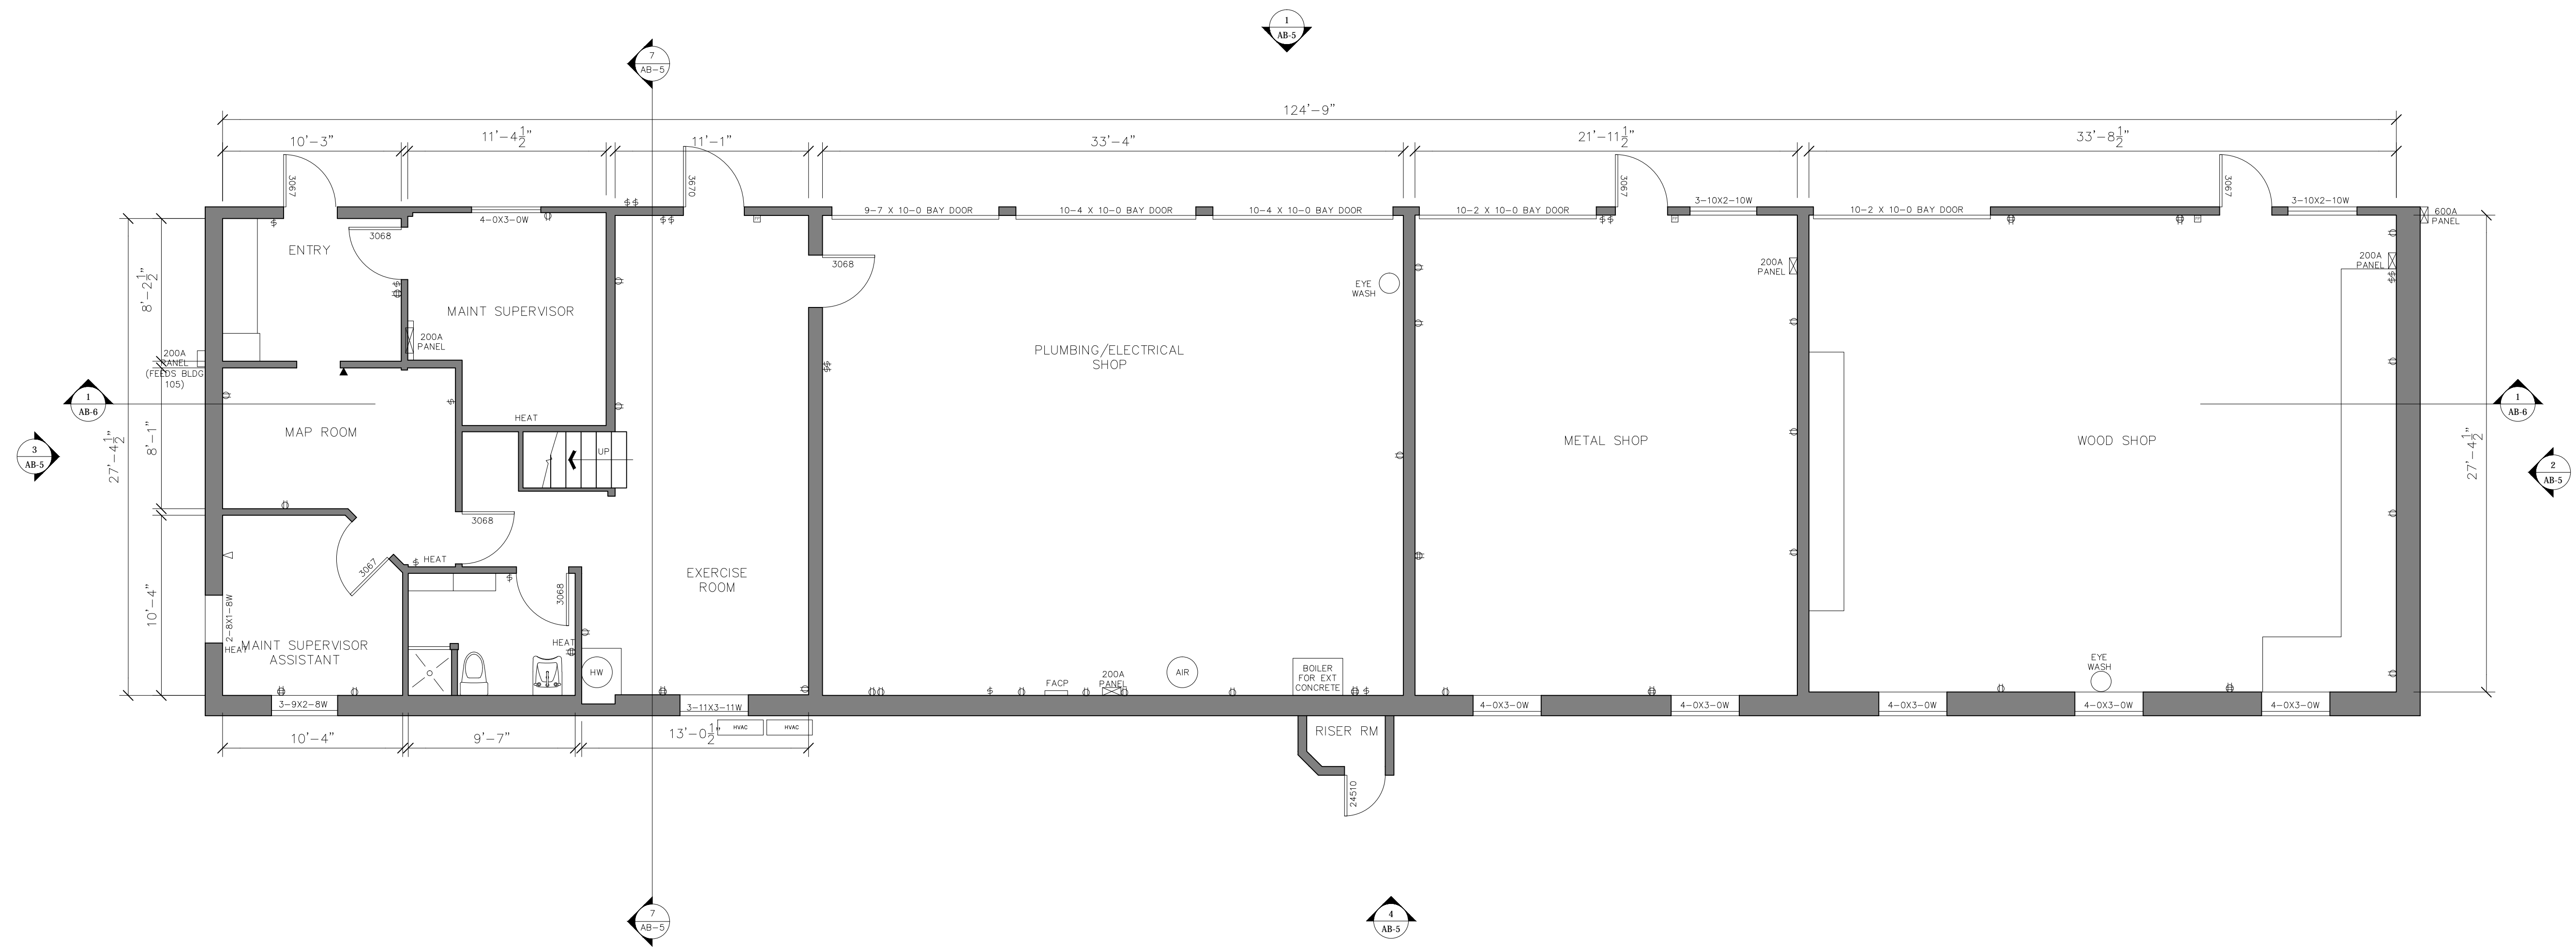

FIRST FLOOR- BUILDING 71 **1**


ARCHITECTURAL AS BUILT
MAINTENANCE FACILITY

NO.	ISSUES REVISIONS	DATE


**BUILDING 71
FLOOR PLAN
AND RCP**

HL	PROJECT MANAGER
HL	PROJECT DIRECTOR
?	PROJECT NUMBER
3/16"=1'-0"	SCALE
MM	DRAWN BY
	SHEET NUMBER


AB-2

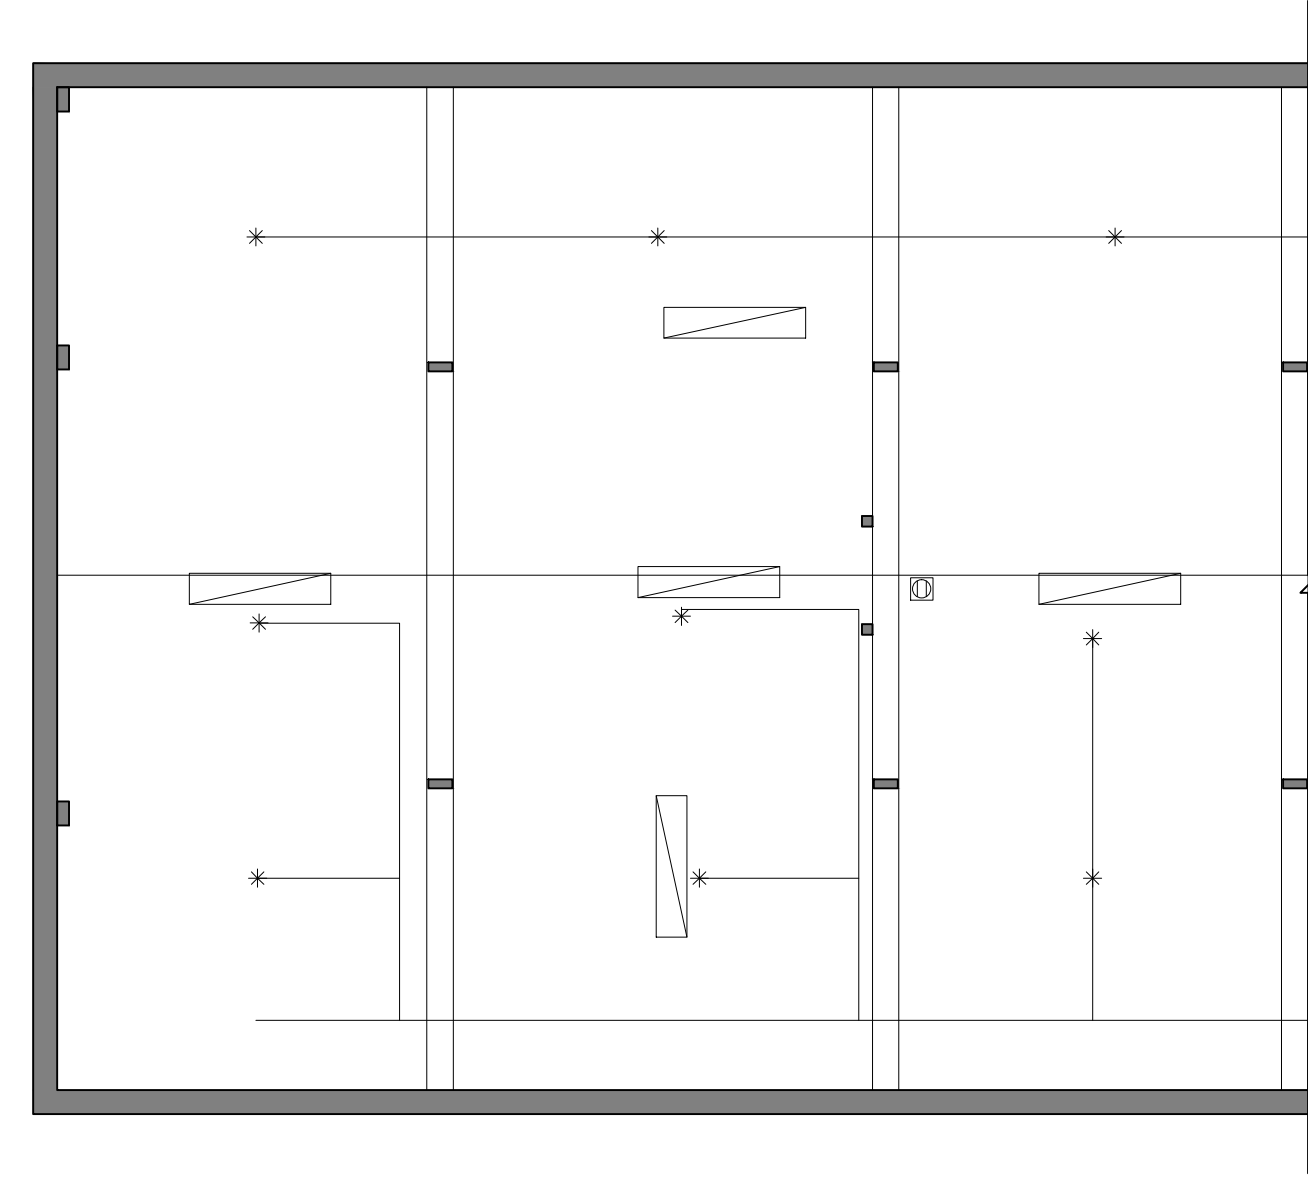


MEZZANINE RCP - BUILDING 71  **6**

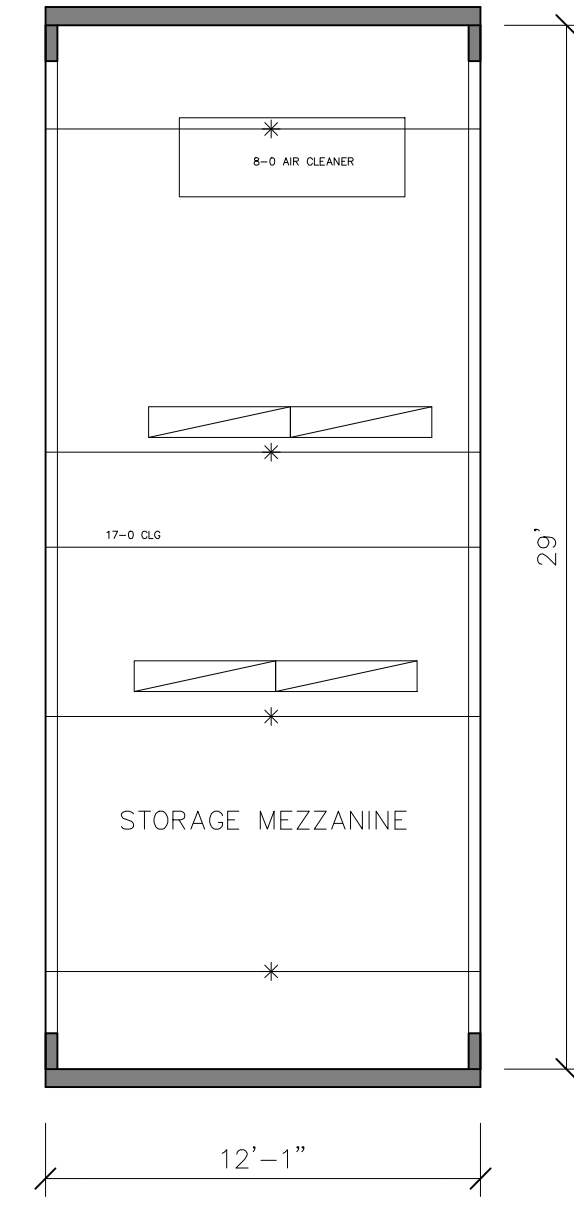


MEZZ RCP - BLDG 77 **5**

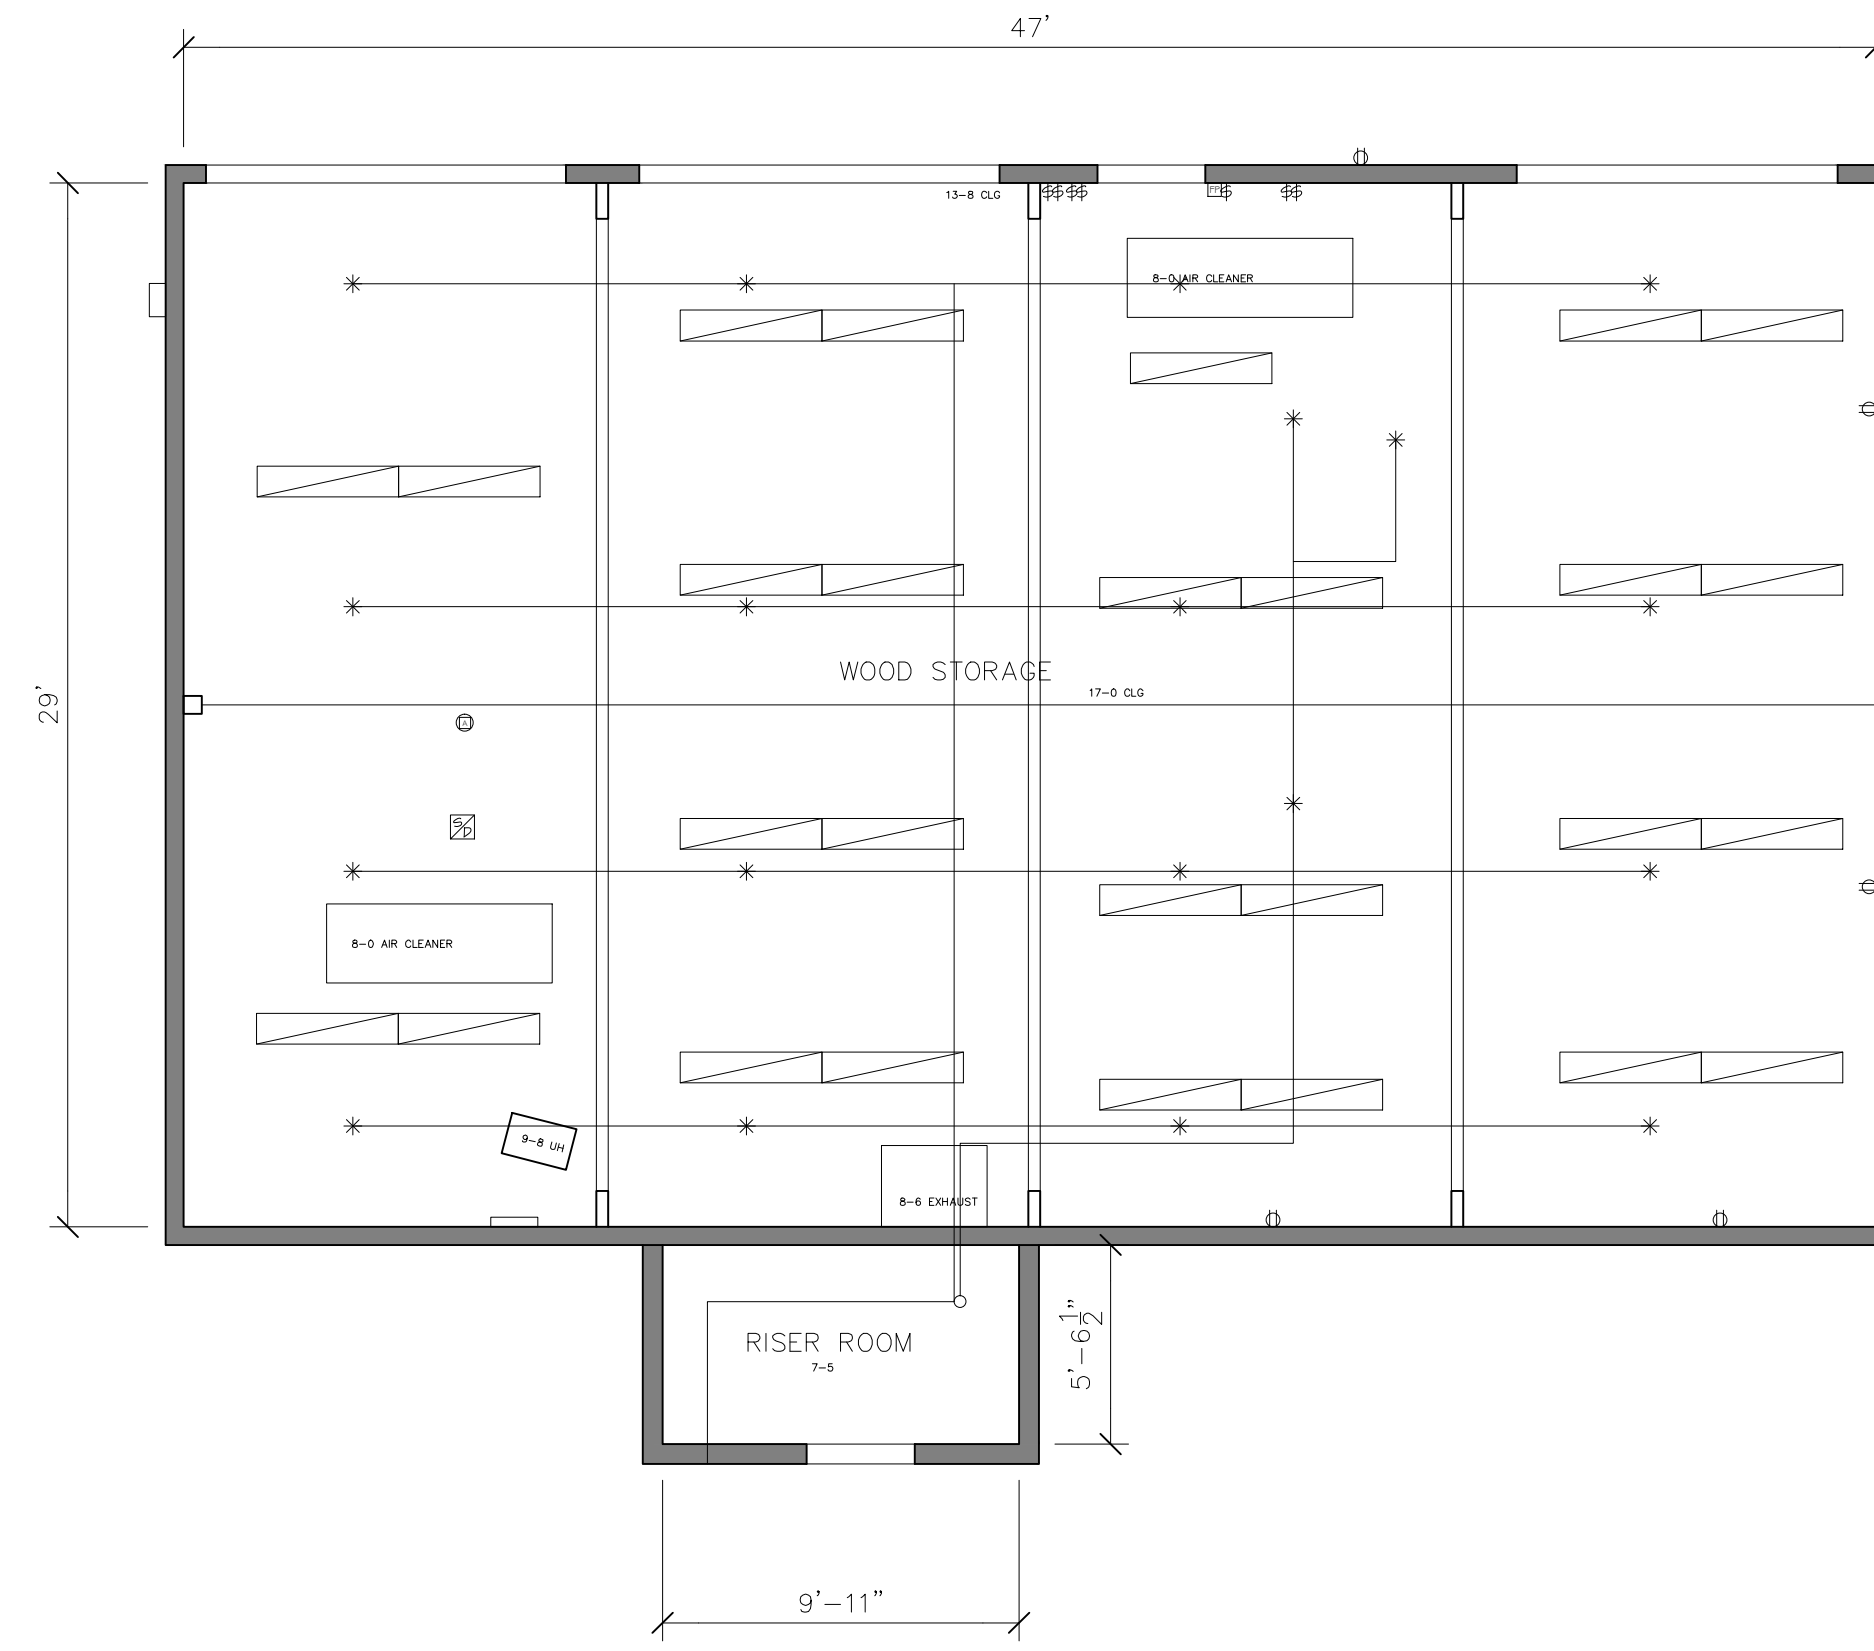


FIRST FLOOR RCP - BUILDING 77  **4**

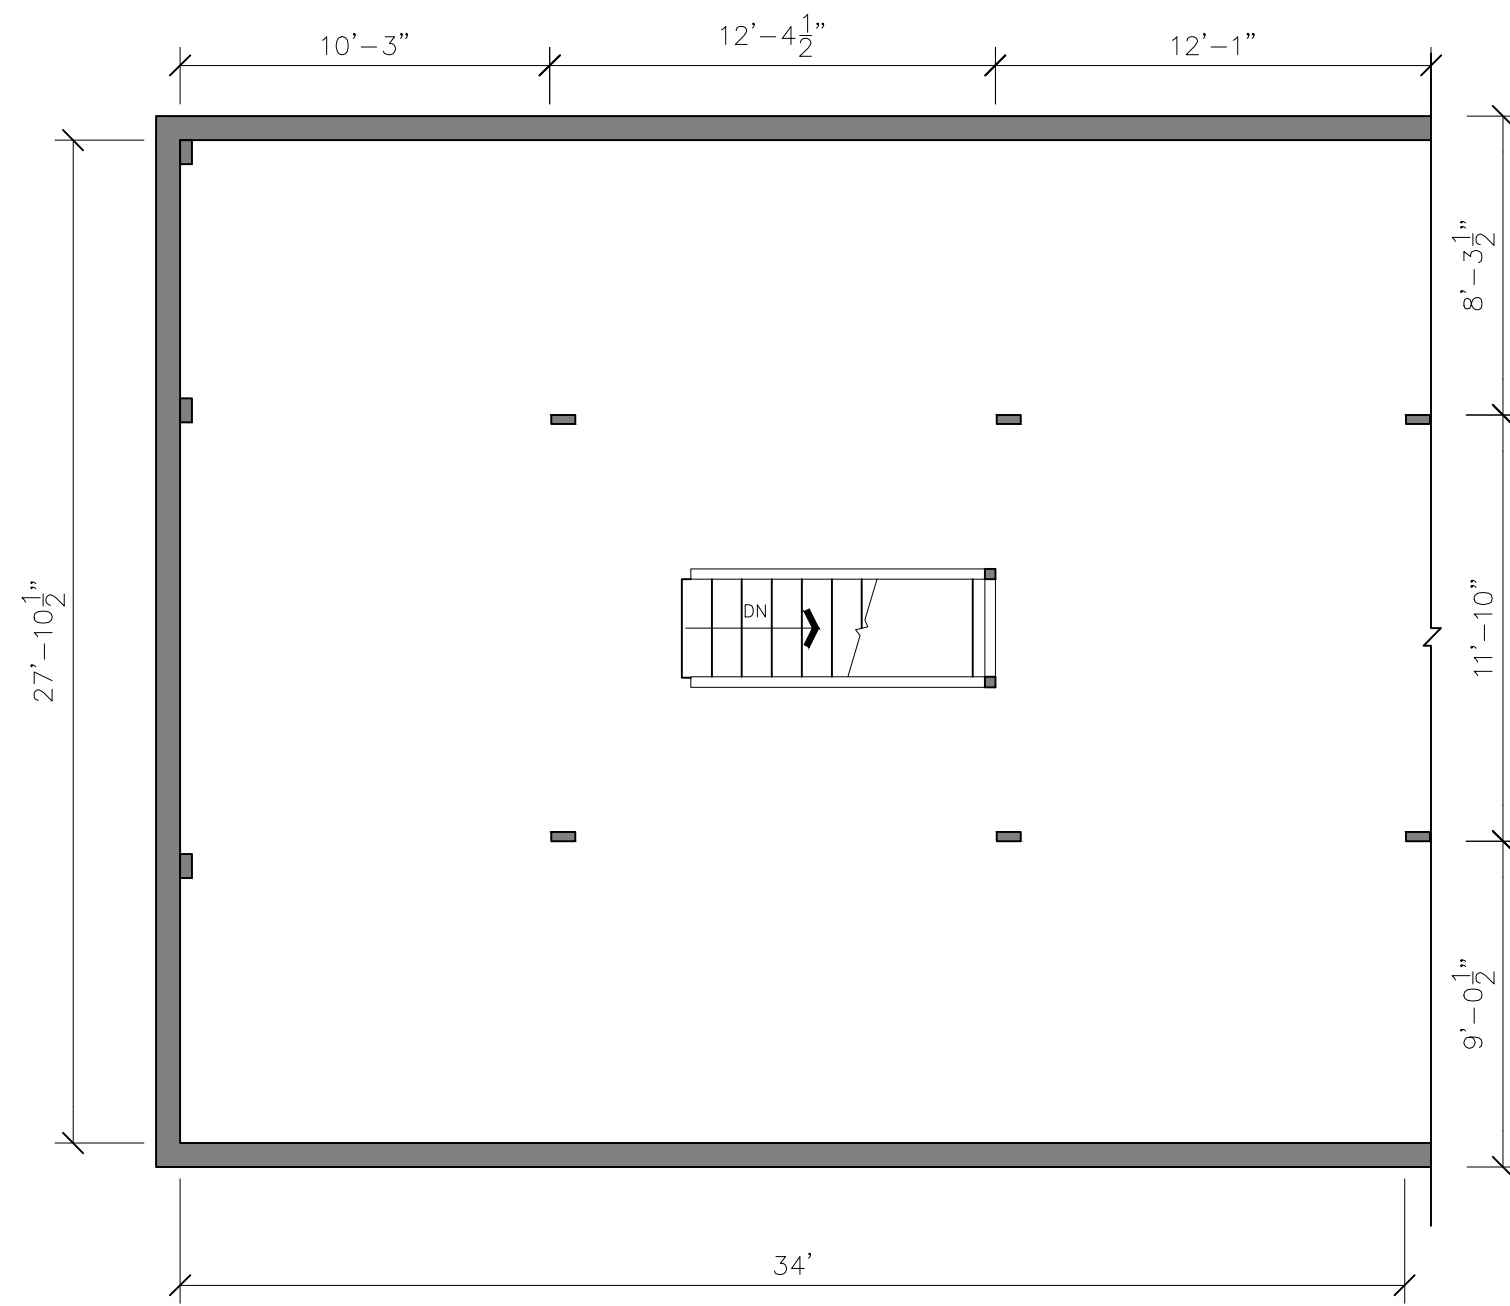

MEZZANINE BUILDING 71  **3**

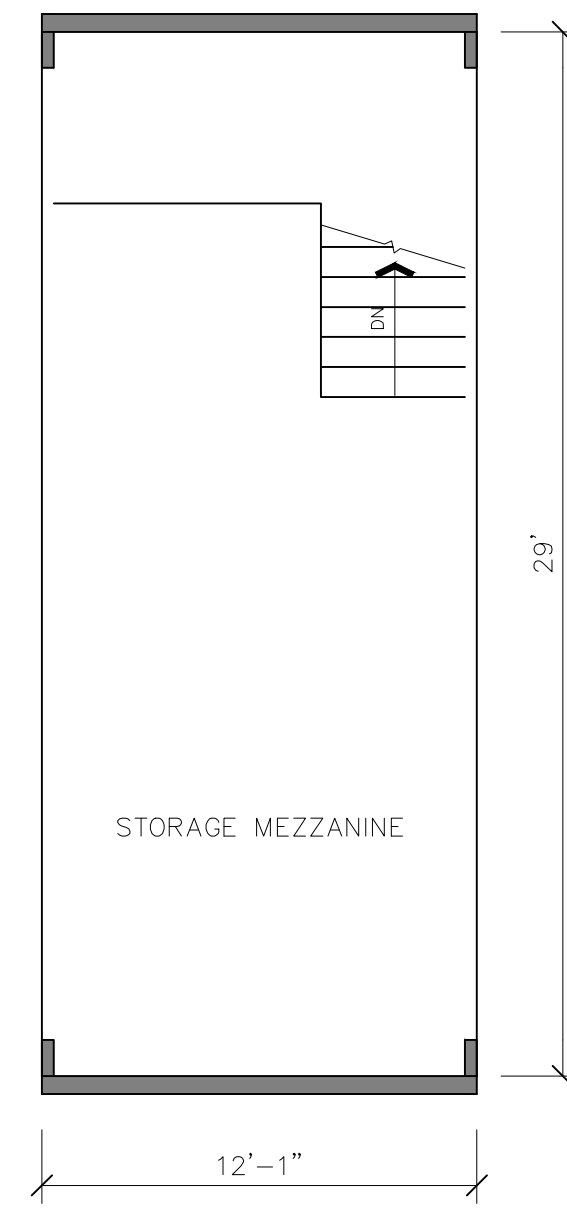

MEZZANINE-BLDG 77 **2**

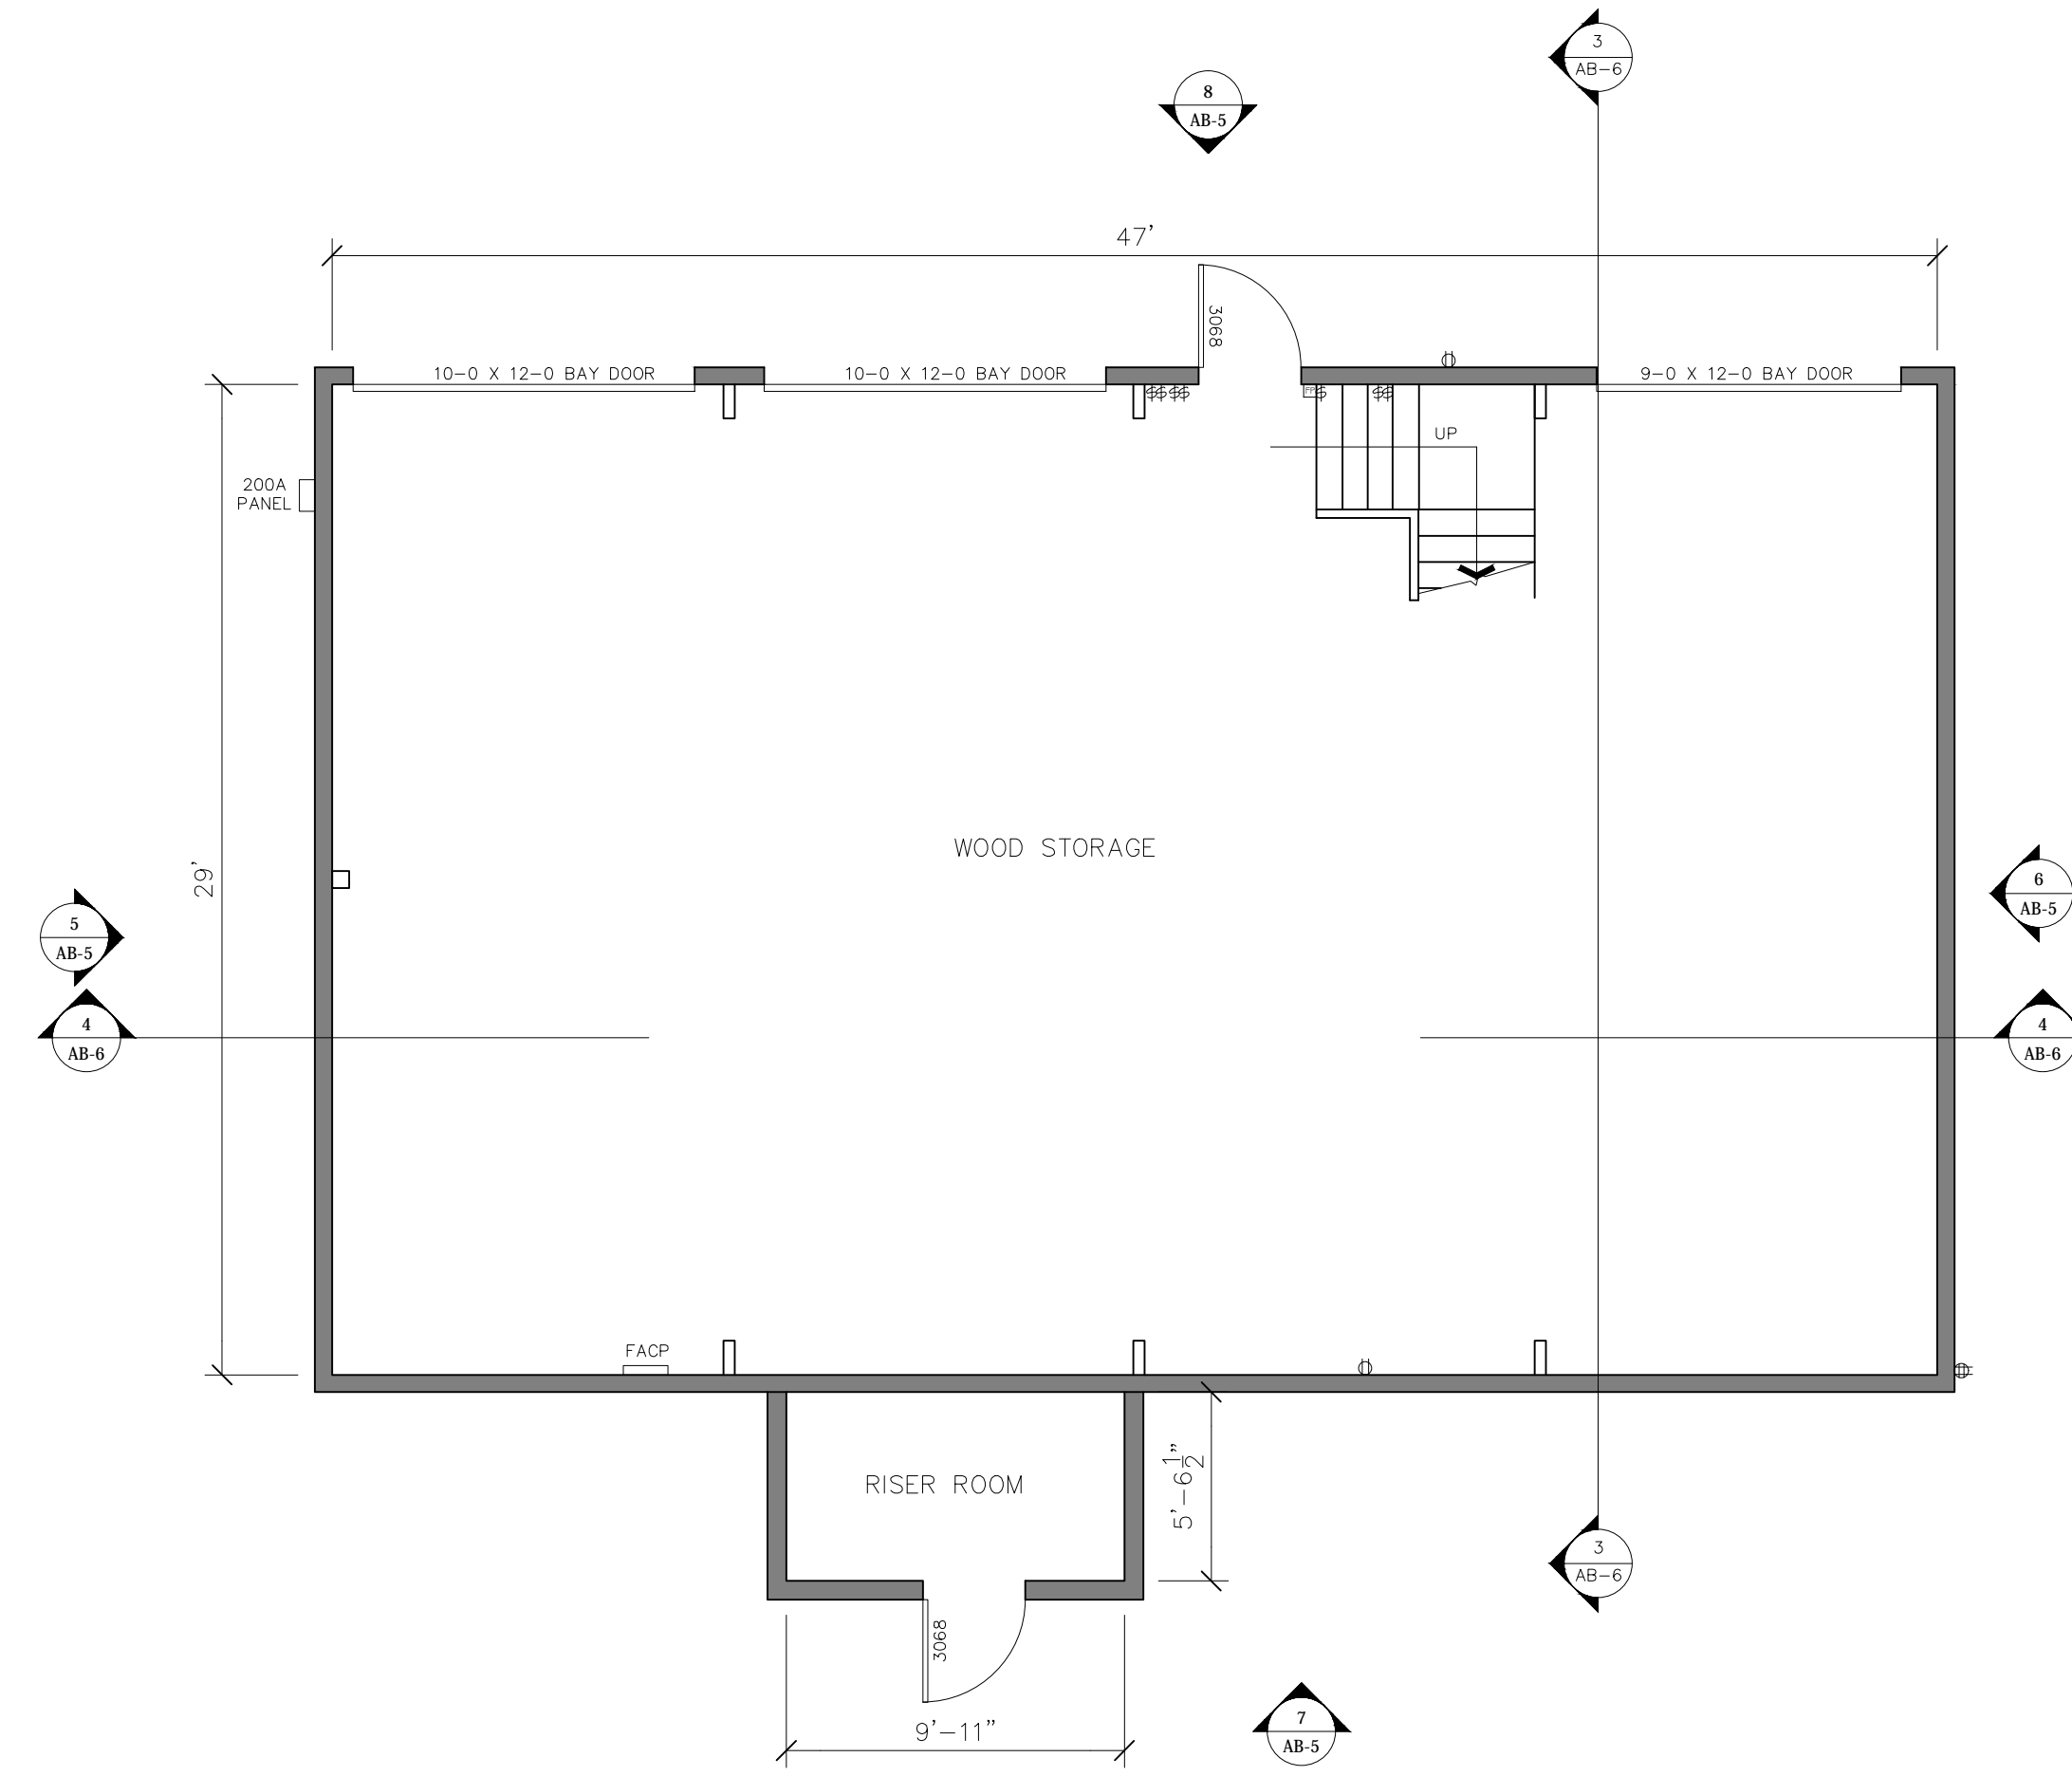

FIRST FLOOR-BUILDING 77  **1**


ARCHITECTURAL AS BUILT
MAINTENANCE FACILITY

NO.	ISSUES REVISIONS	DATE


SHEET TITLE
**BUILDING 77
FLOOR PLAN
AND RCP**

HL	PROJECT MANAGER
HL	PROJECT DIRECTOR
?	PROJECT NUMBER
3/16"=1'-0"	SCALE
MM	DRAWN BY
	SHEET NUMBER


AB-3

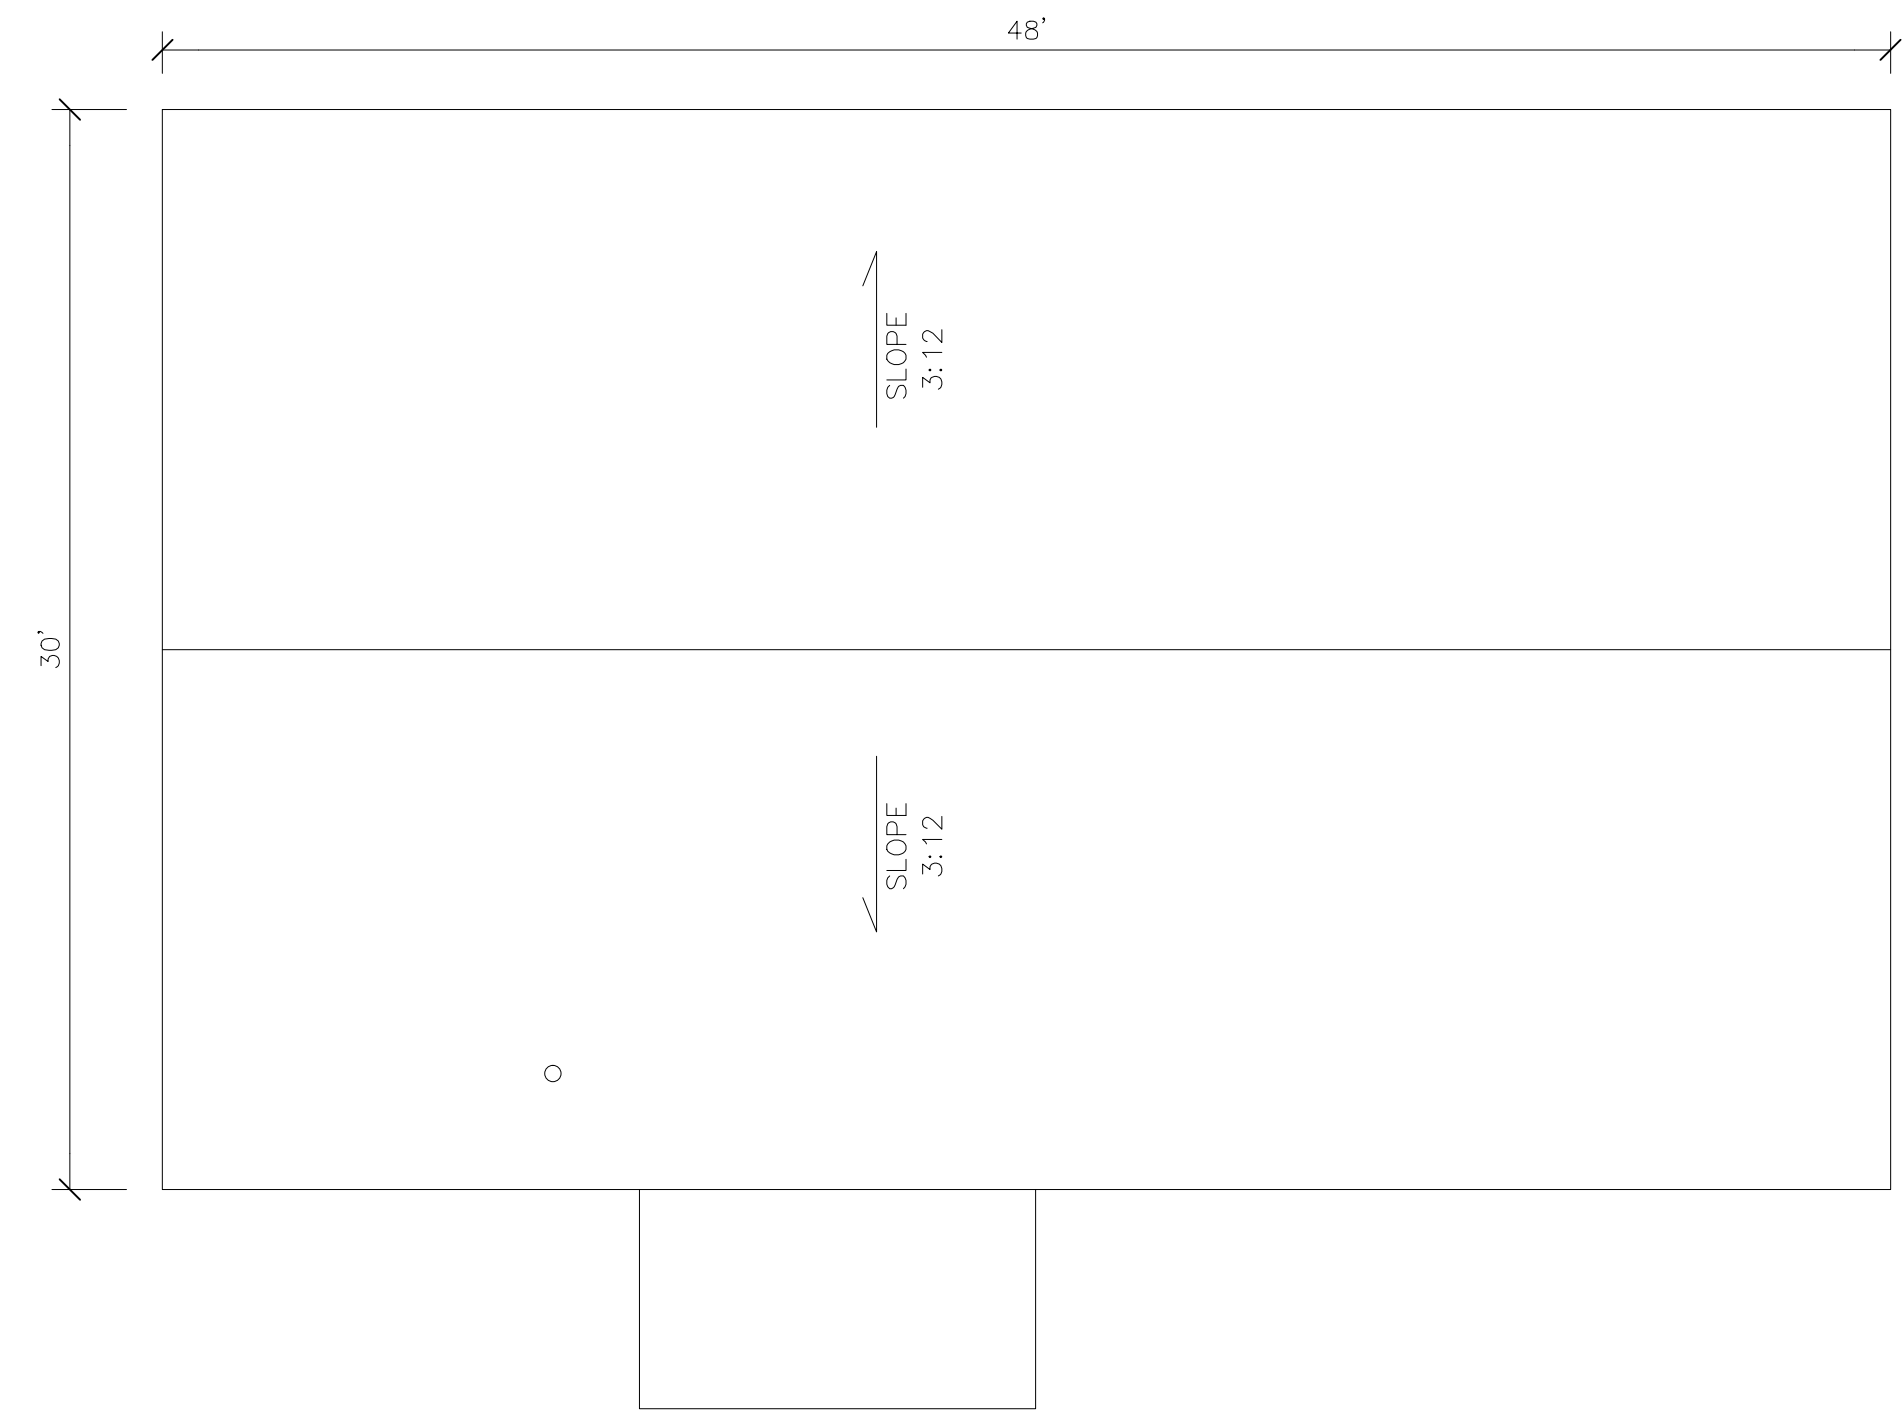

BUILDING 77 ROOF PLAN  **3**

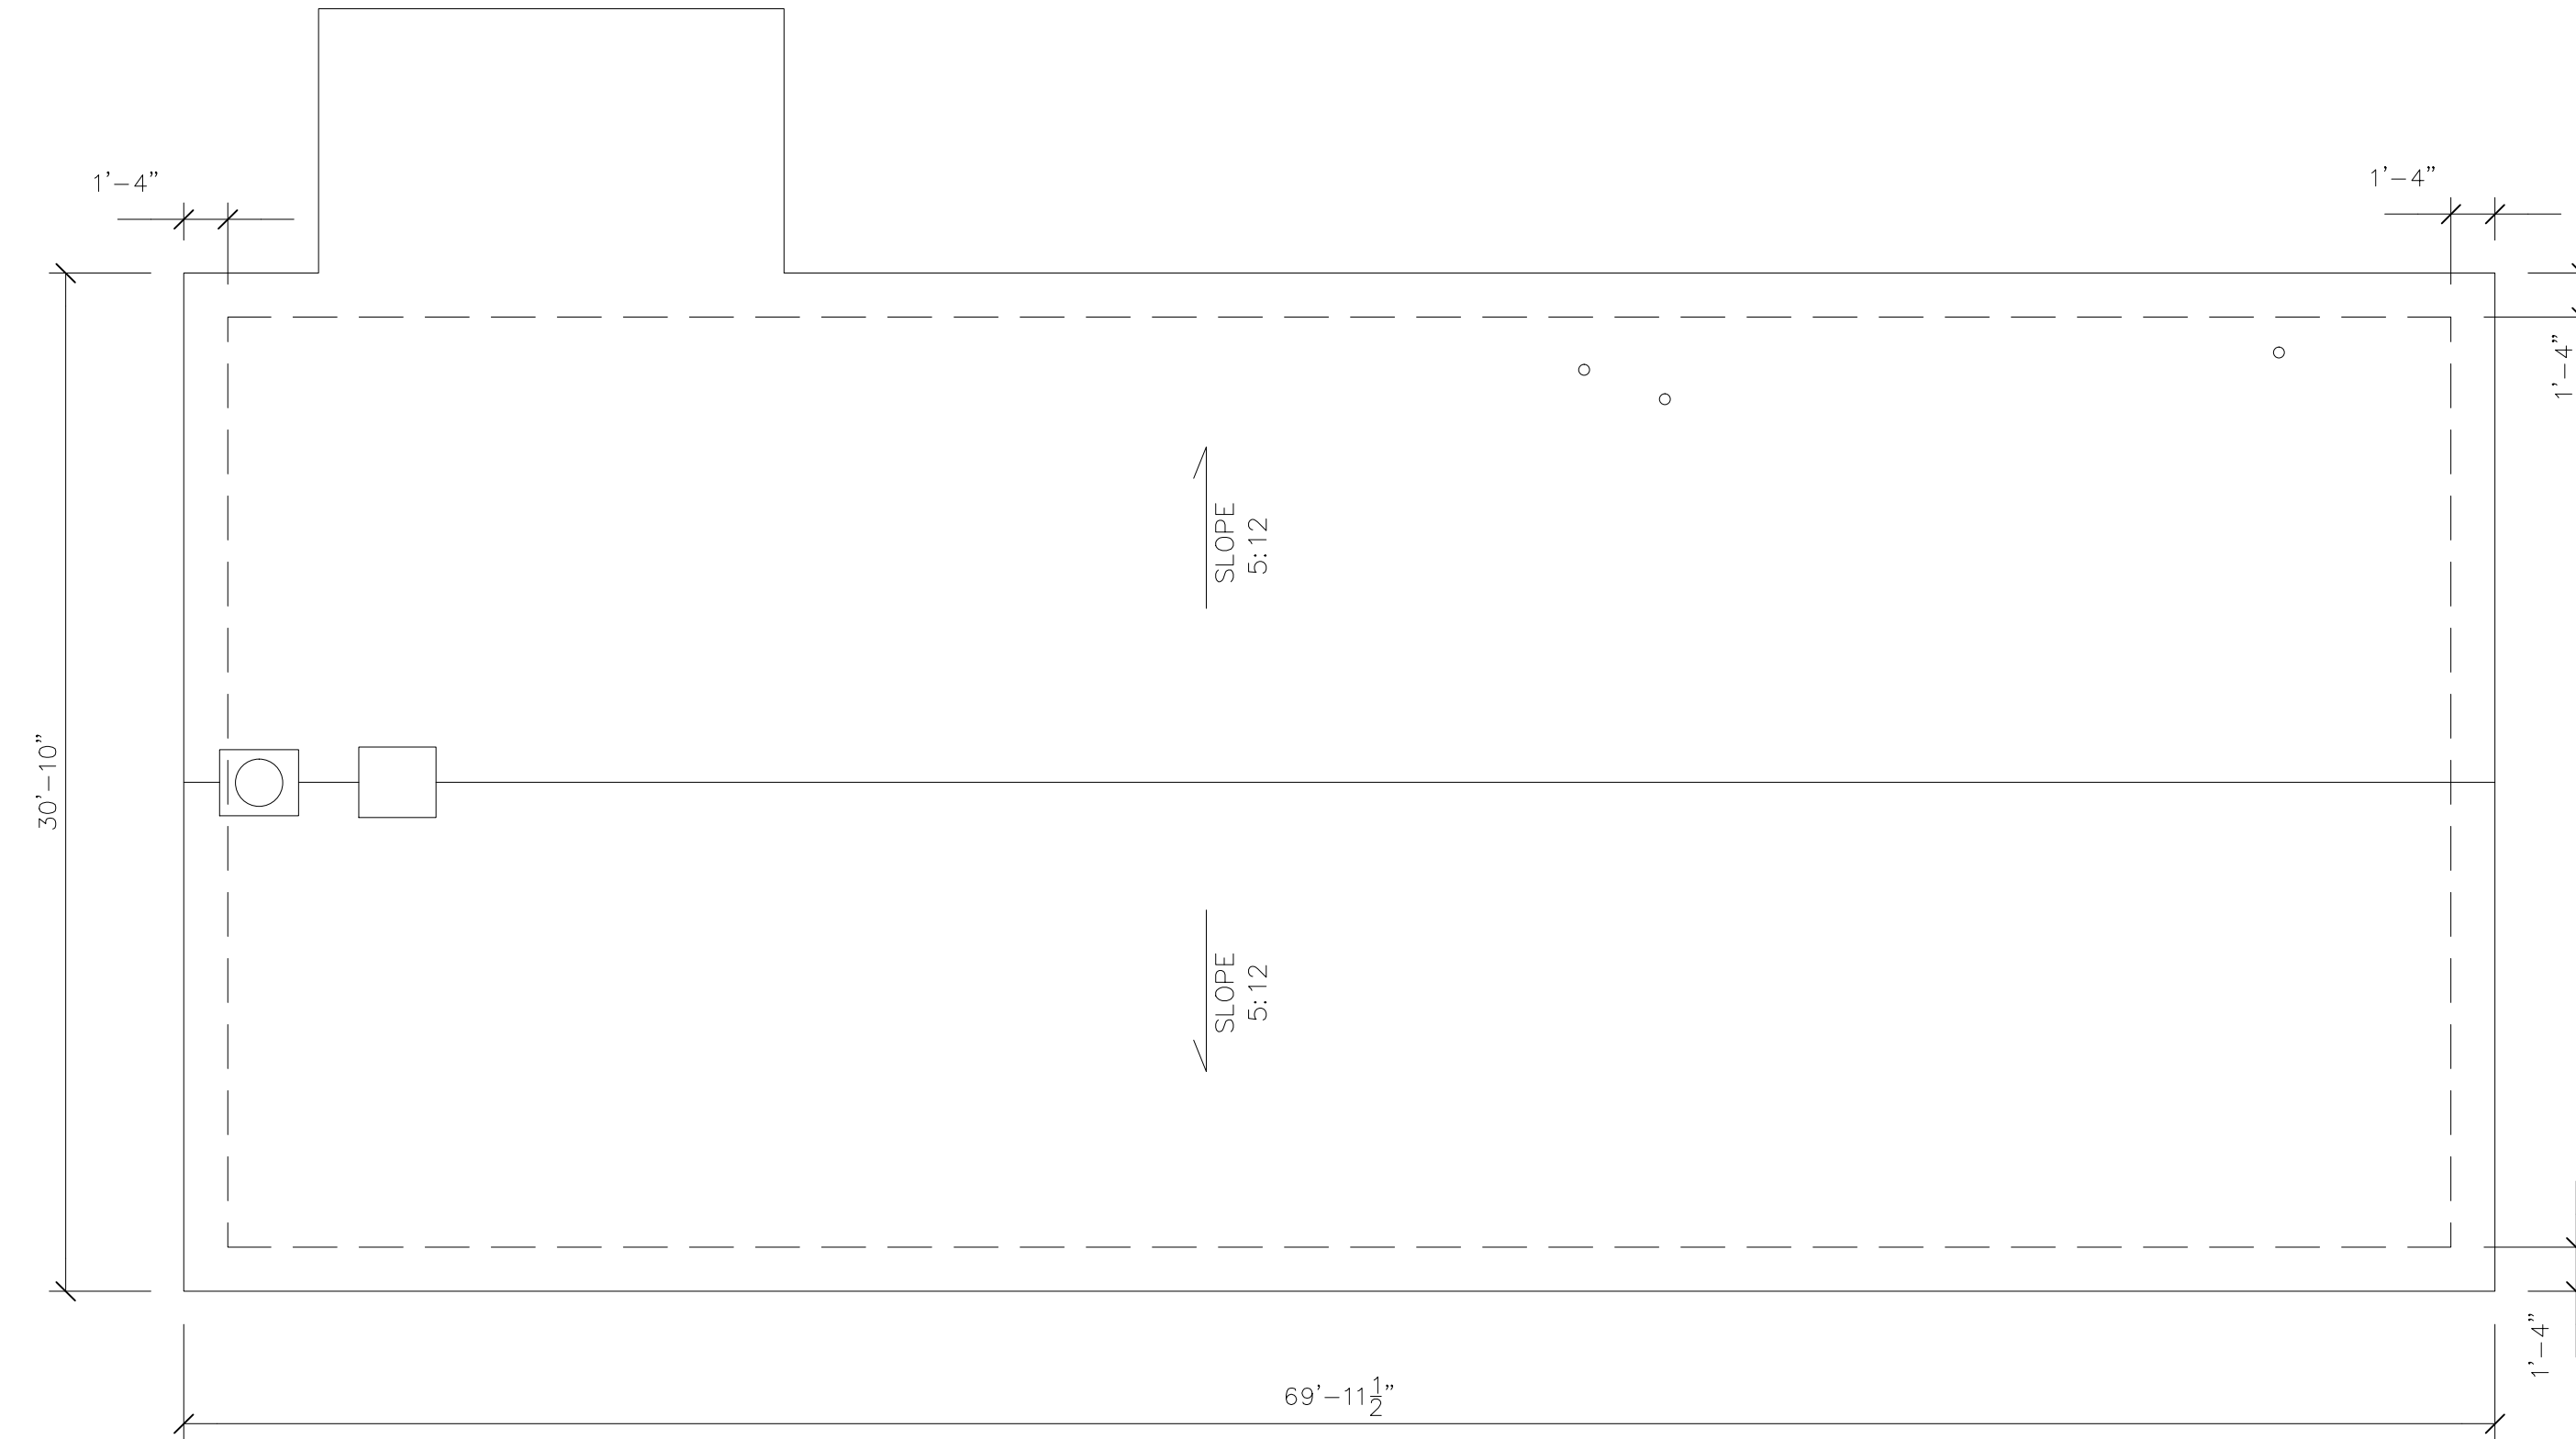

BUILDING 70 ROOF PLAN  **2**

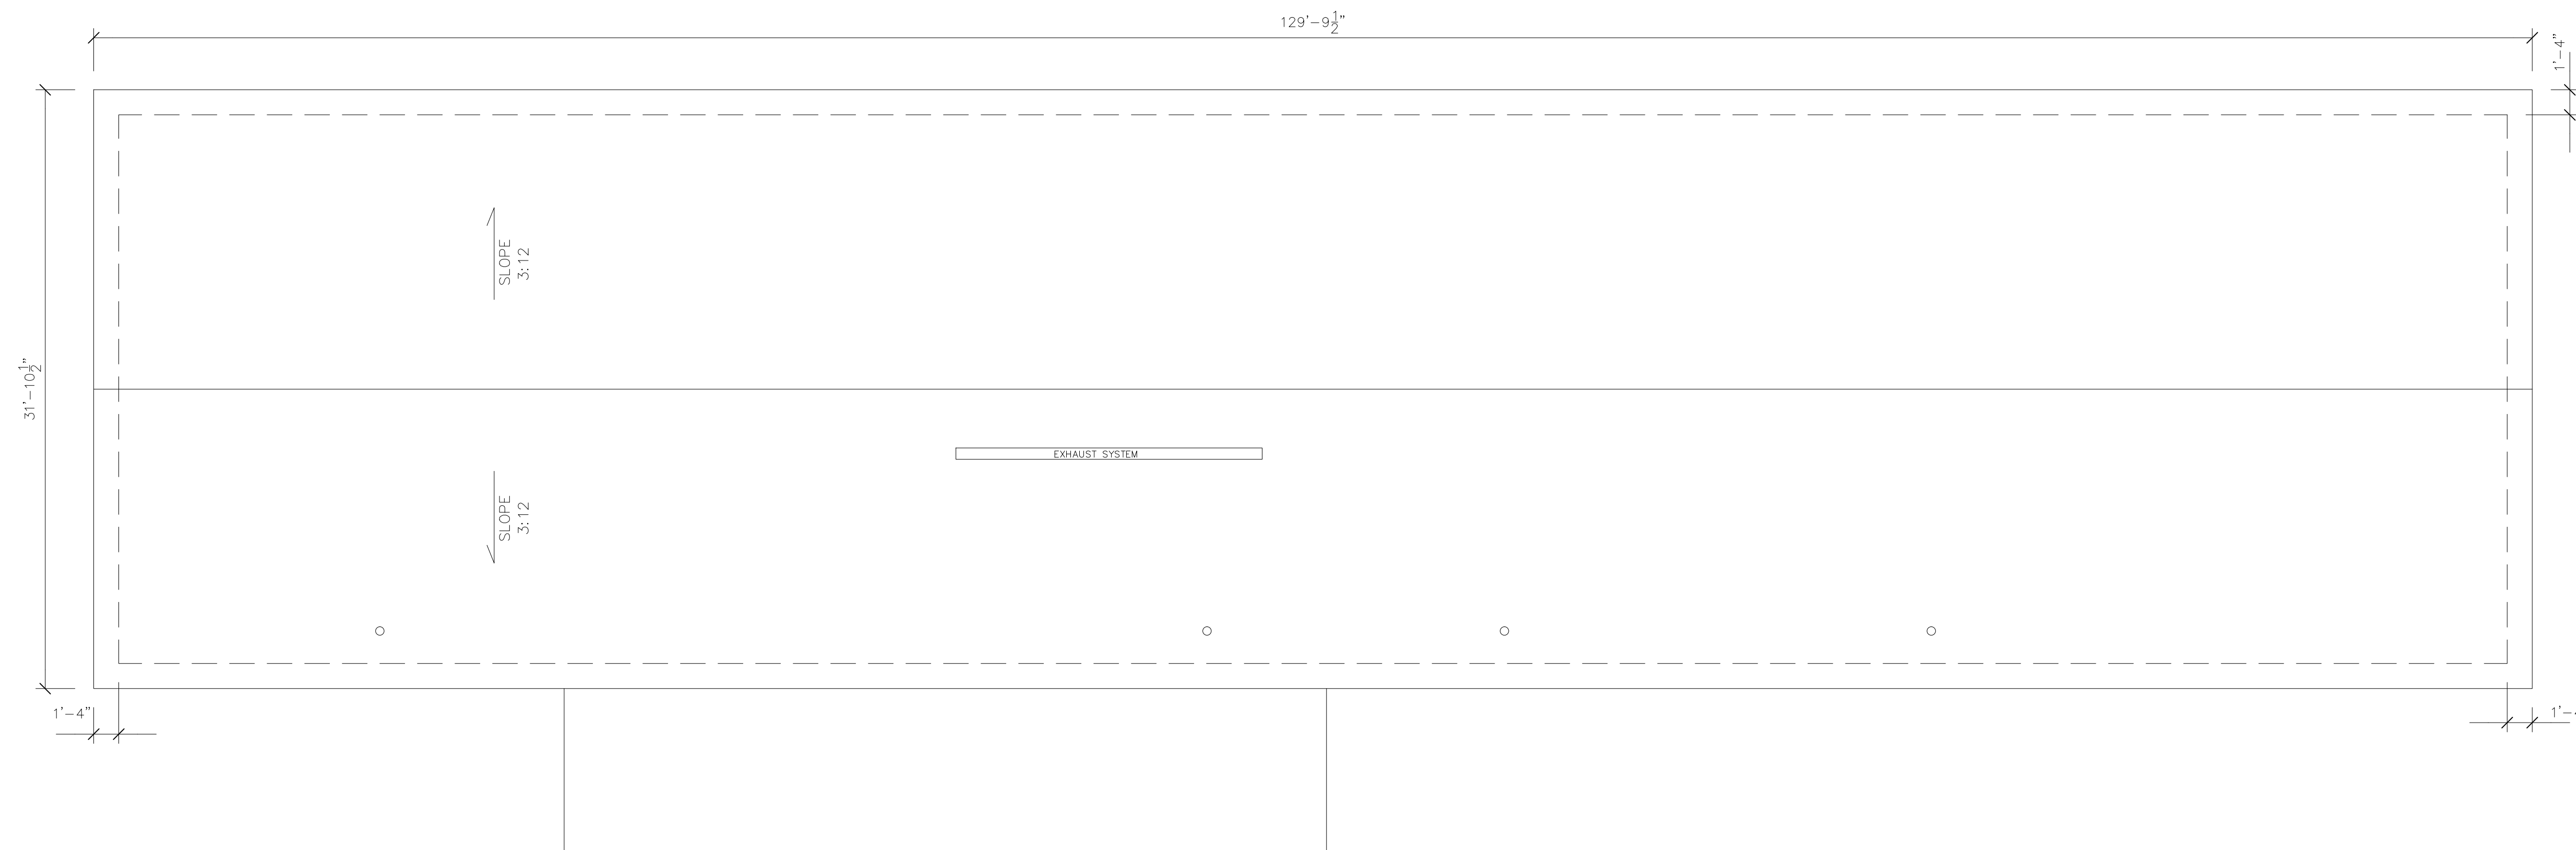

BUILDING 71 ROOF PLAN  **1**

NO.	ISSUES REVISIONS	DATE


SHEET TITLE

ROOF PLANS


HL	PROJECT MANAGER
HL	PROJECT DIRECTOR
?	PROJECT NUMBER
	SCALE
MM	DRAWN BY
	SHEET NUMBER

3/16"=1'-0"


ARCHITECTURAL AS BUILT
MAINTENANCE FACILITY

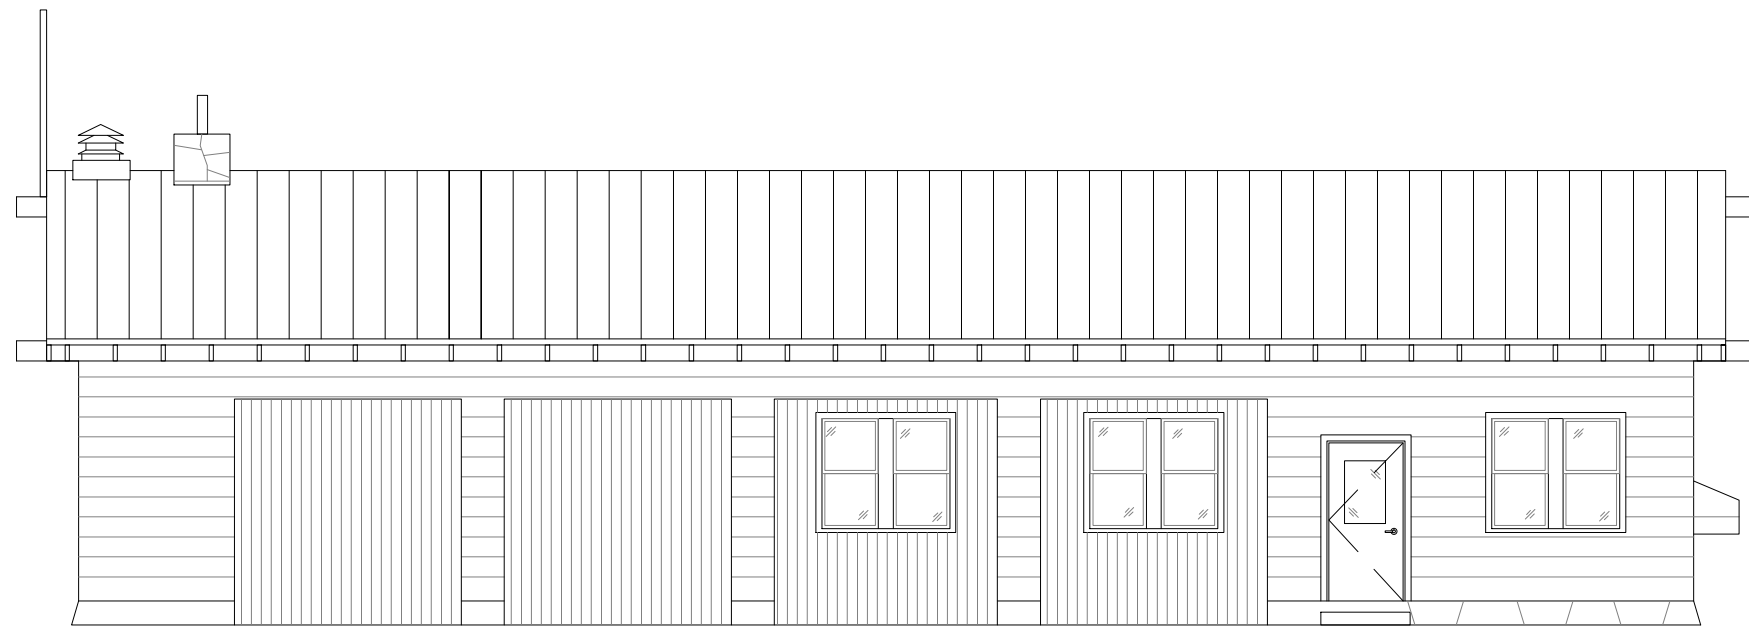


12 SOUTH ELEVATION BLDG 70

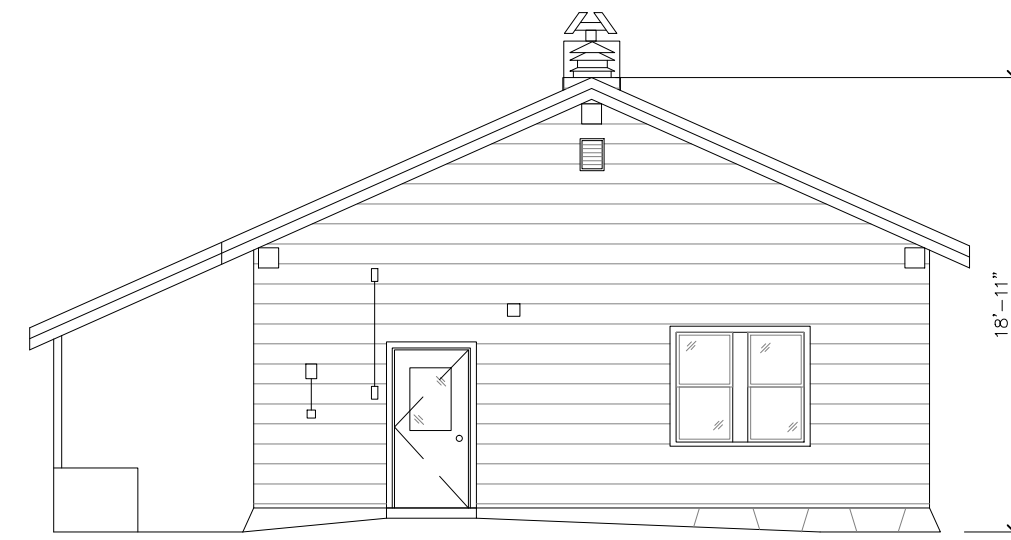

11 WEST ELEVATION BLDG 70

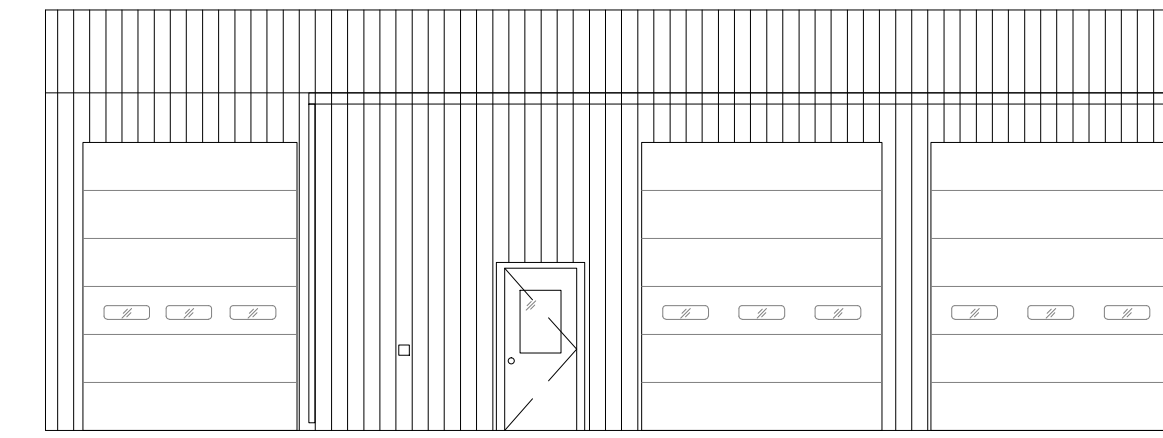


8 NORTH ELEVATION BLDG 77

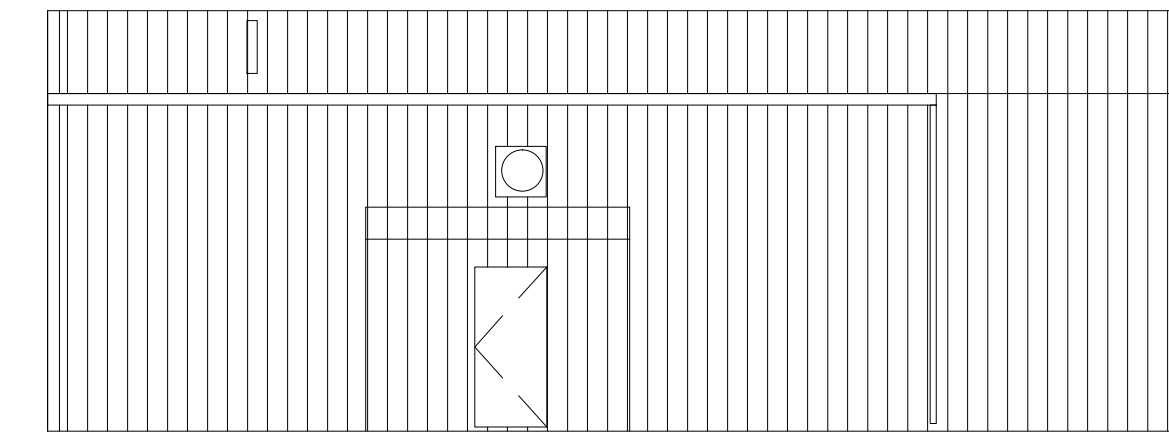


7 SOUTH ELEVATION BLDG 77



10 NORTH ELEVATION BLDG 70

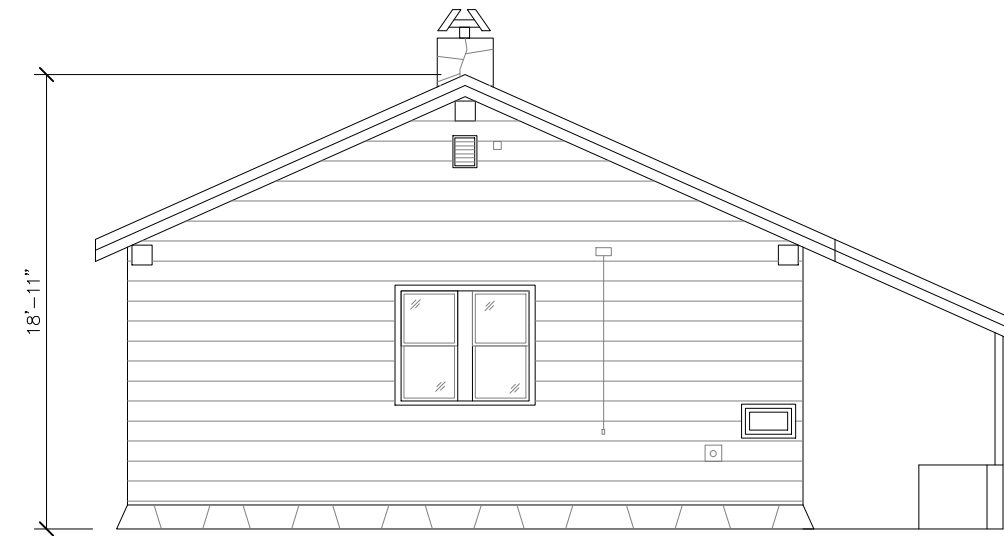


9 EAST ELEVATION BLDG 70

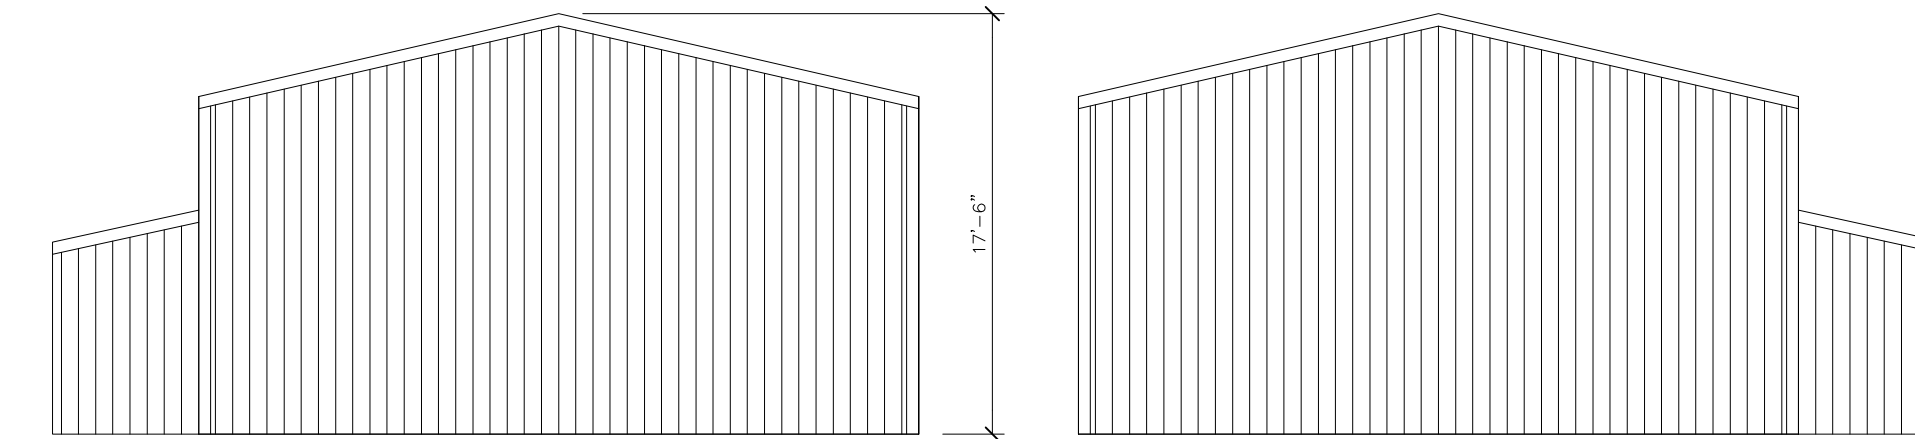


6 EAST ELEVATION BLDG 77


5 WEST ELEVATION BLDG 77

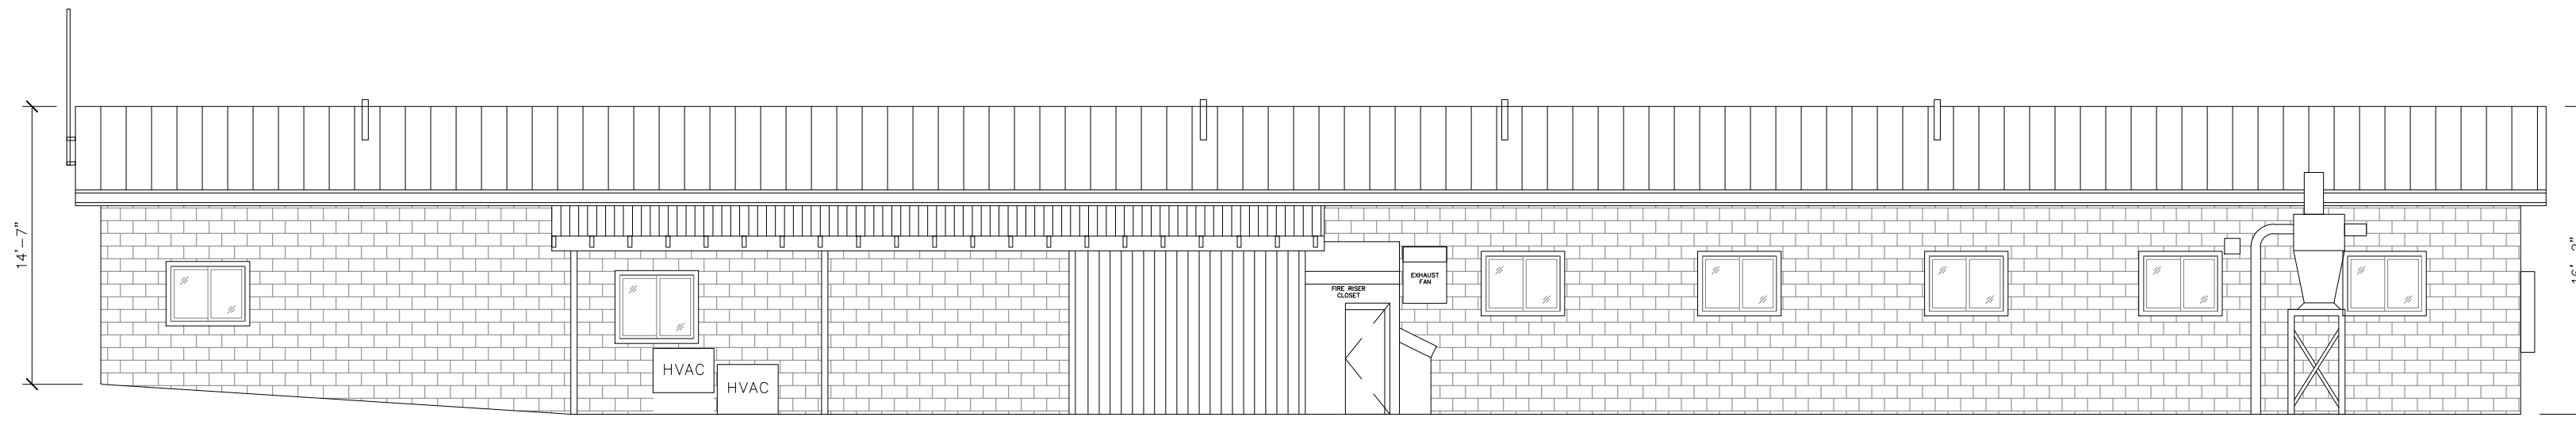


4 SOUTH ELEVATION BLDG 71

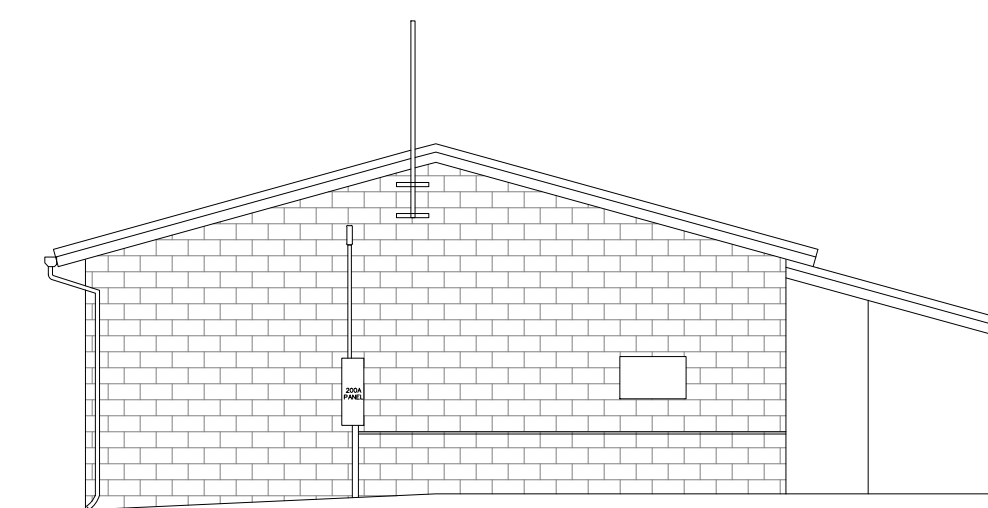

3 WEST ELEVATION BLDG 71

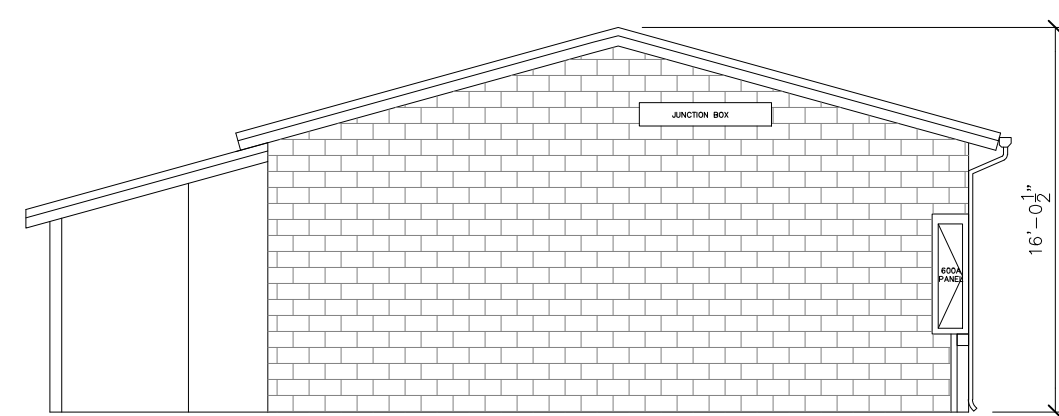

2 EAST ELEVATION BLDG 71

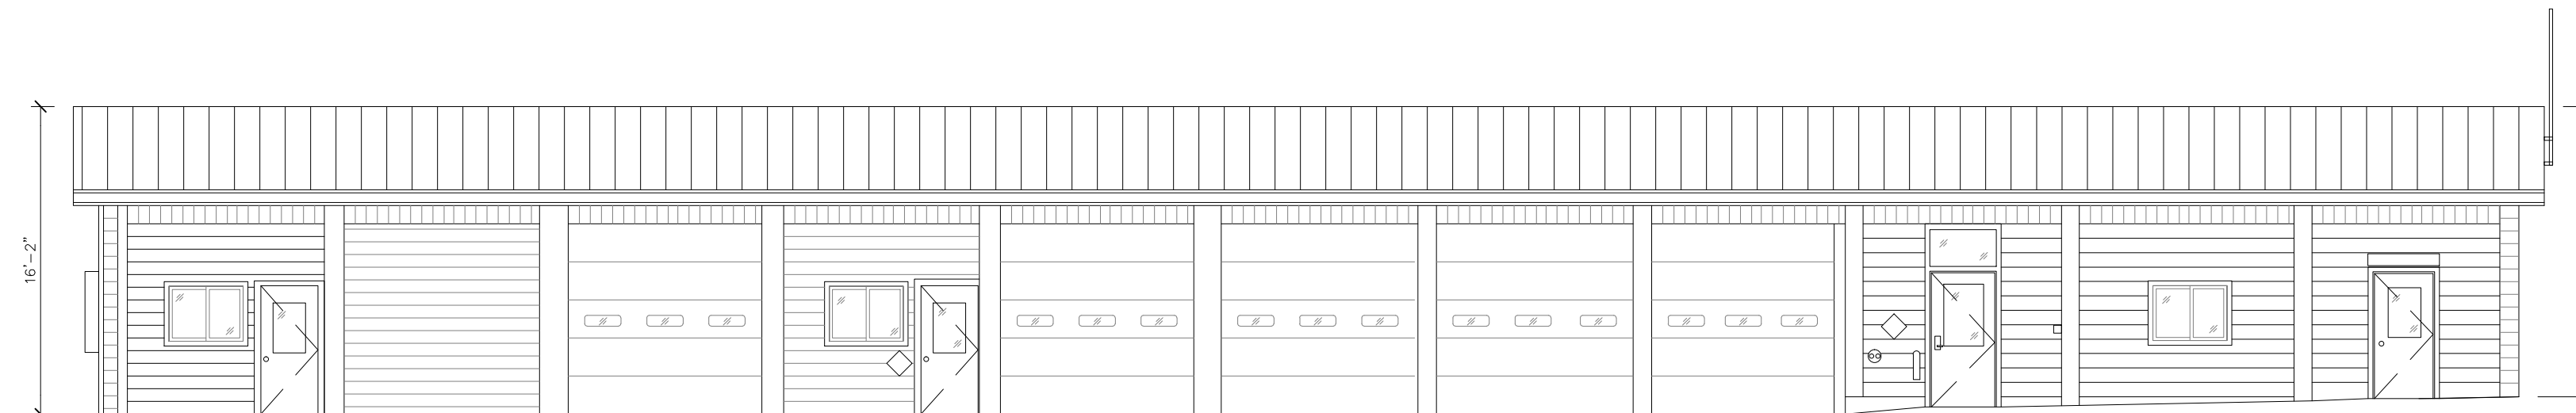

1 NORTH ELEVATION BLDG 71

NO.	ISSUES REVISIONS	DATE

SHEET TITLE
EXTERIOR ELEVATIONS

HL	PROJECT MANAGER
HL	PROJECT DIRECTOR
?	PROJECT NUMBER
1/8"=1'-0"	SCALE
MM	DRAWN BY
	SHEET NUMBER


ARCHITECTURAL AS BUILT
MAINTENANCE FACILITY

NO.	ISSUES REVISIONS	DATE


BUILDING SECTIONS

HL	PROJECT MANAGER
HL	PROJECT DIRECTOR
?	PROJECT NUMBER
?	PROJECT NUMBER
3/16"=1'-0"	SCALE
MM	DRAWN BY
	SHEET NUMBER


AB-6

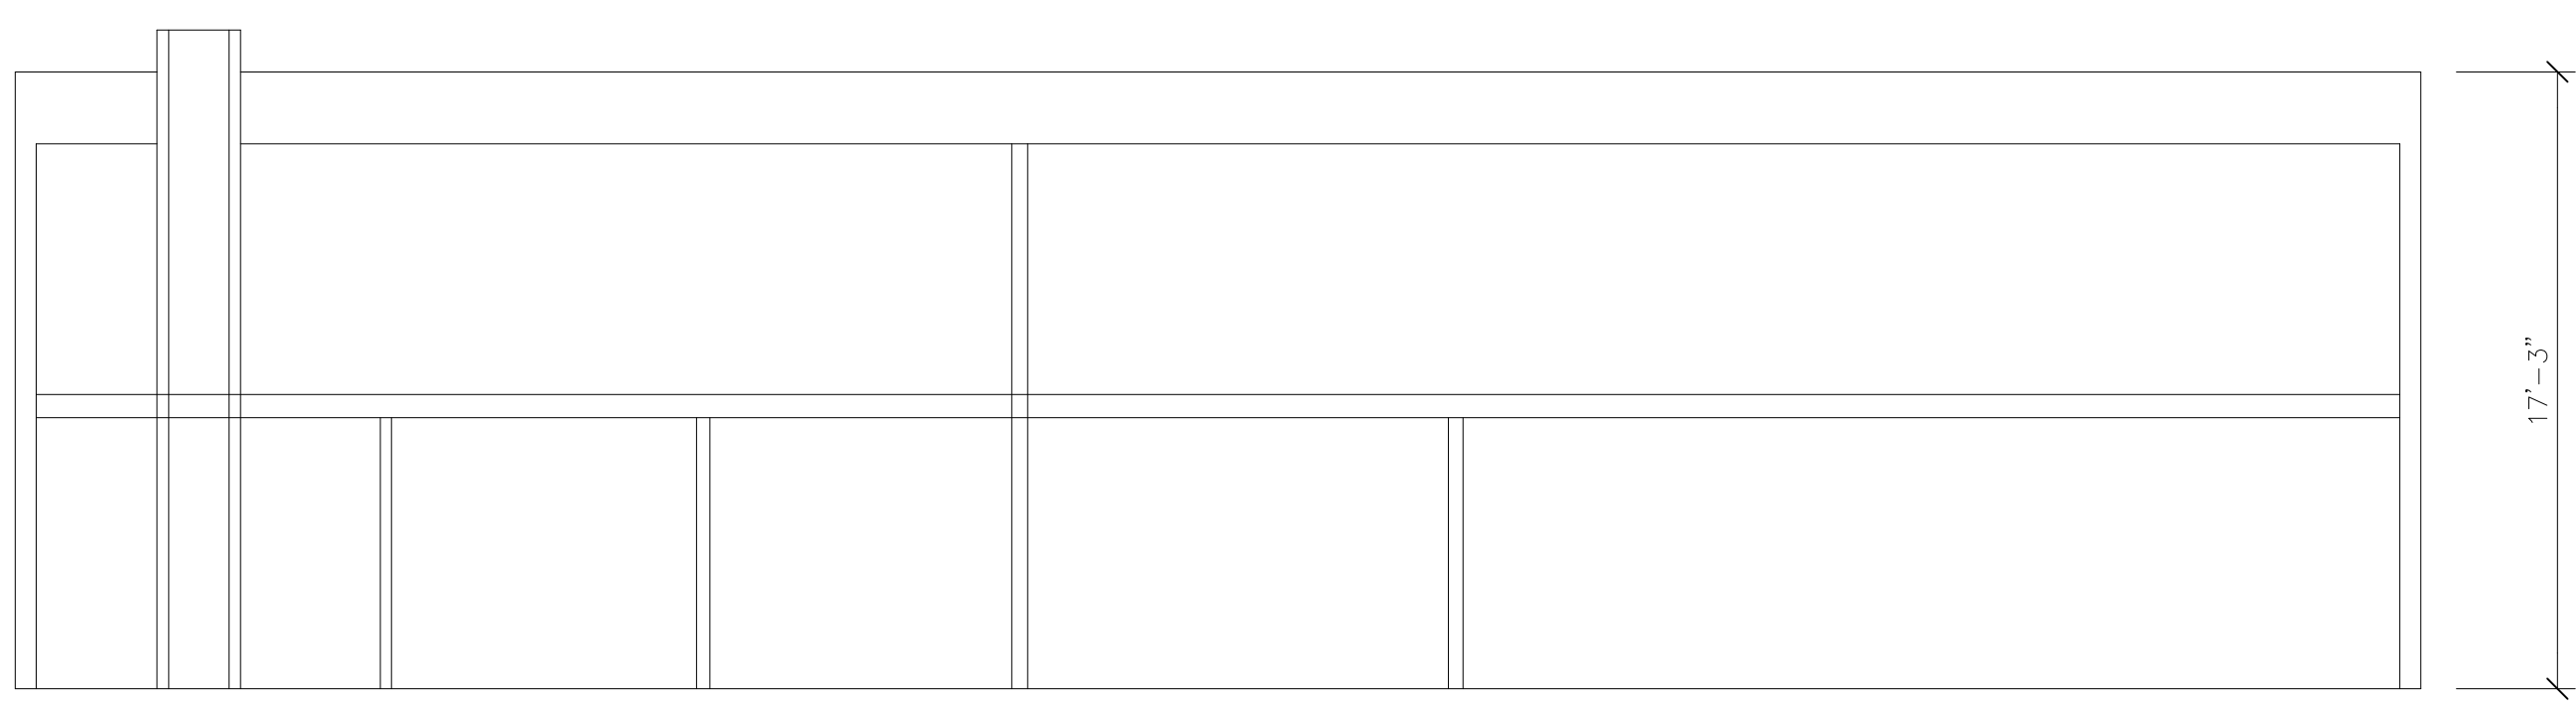


⑤ SECTION – BLDG 70

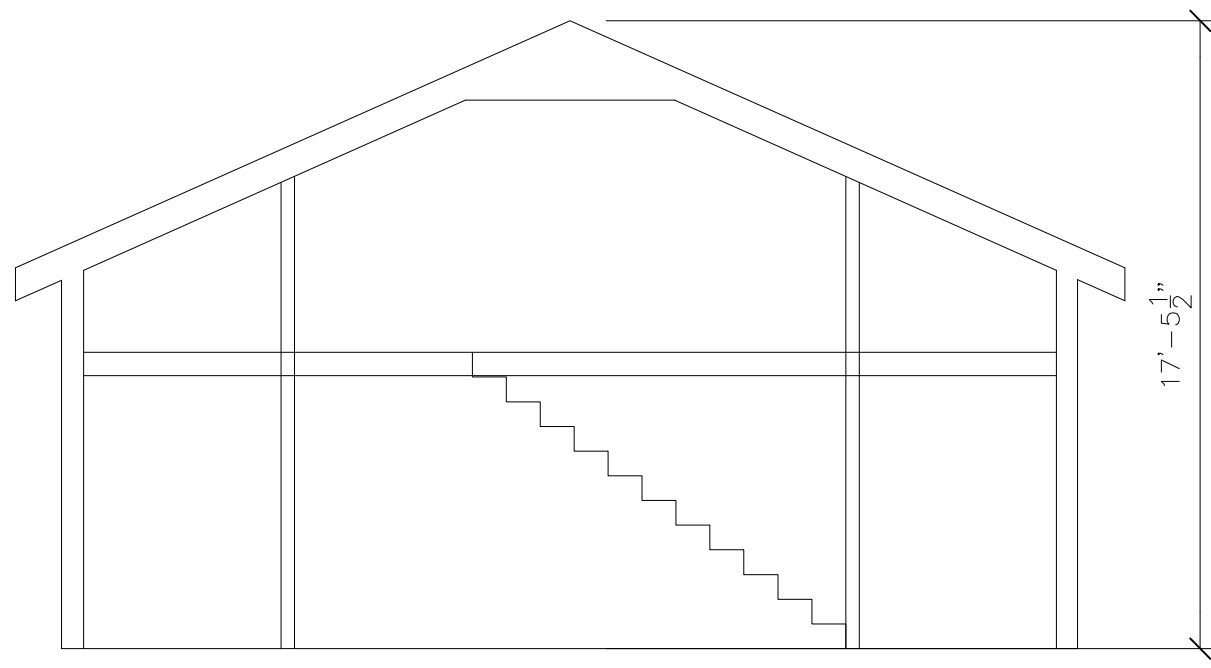


⑥ SECTION – BLDG 70

 


④ SECTION – BLDG 77

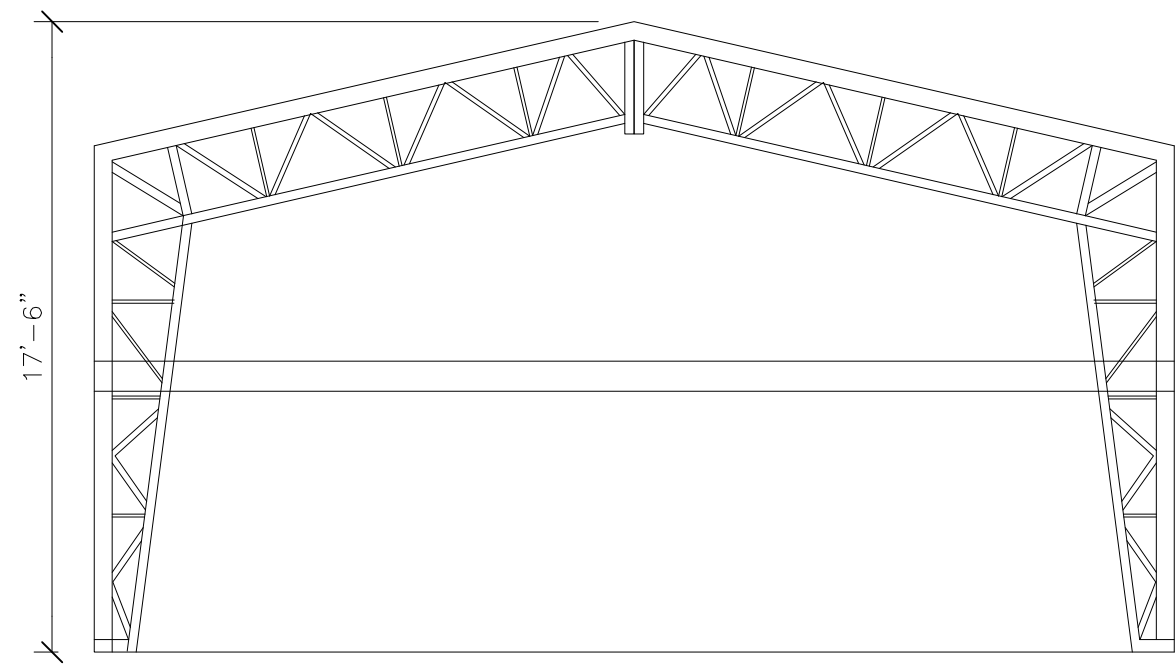

③ SECTION – BLDG 77

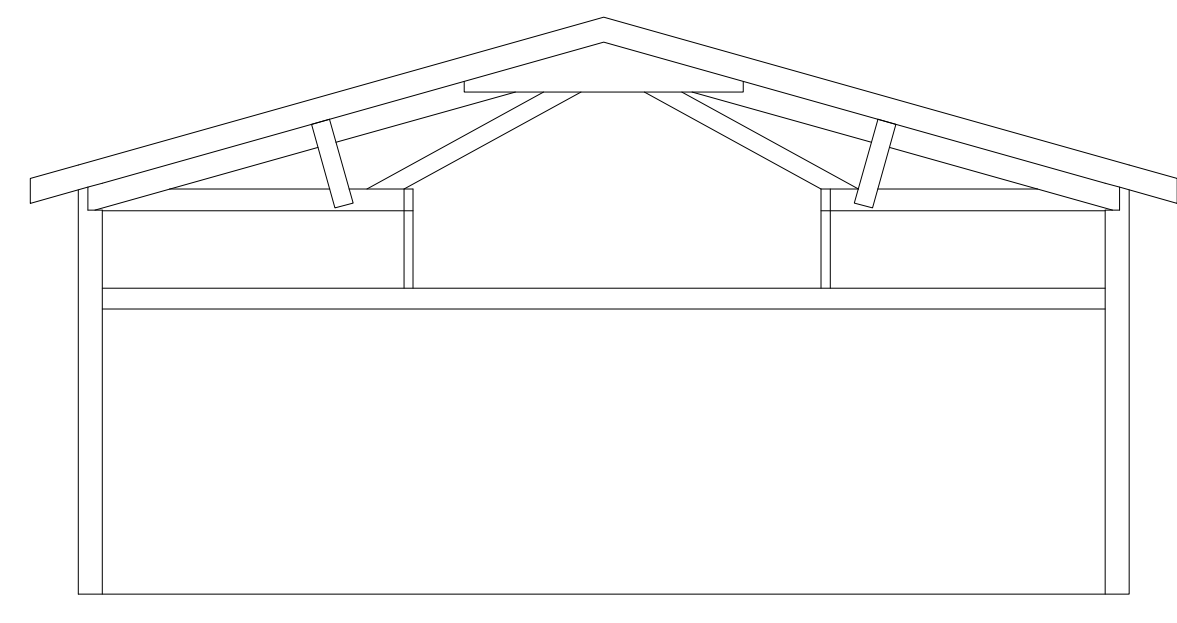

② SECTION – BLDG 71

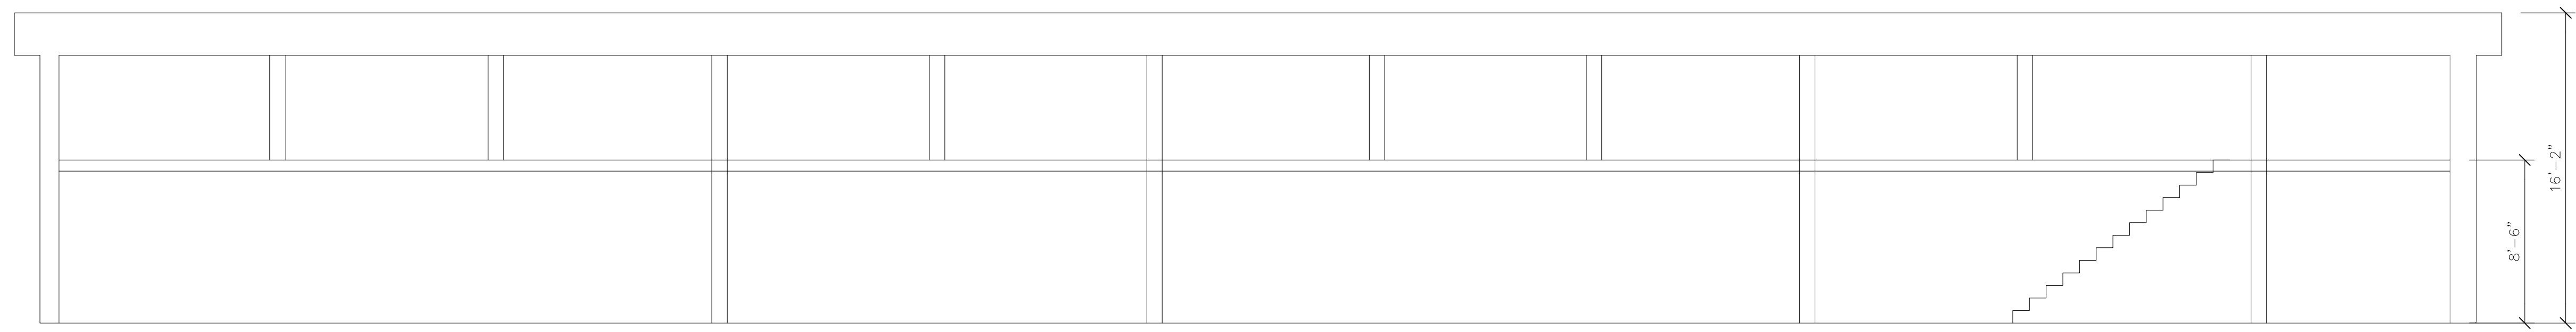

① SECTION – BLDG 71