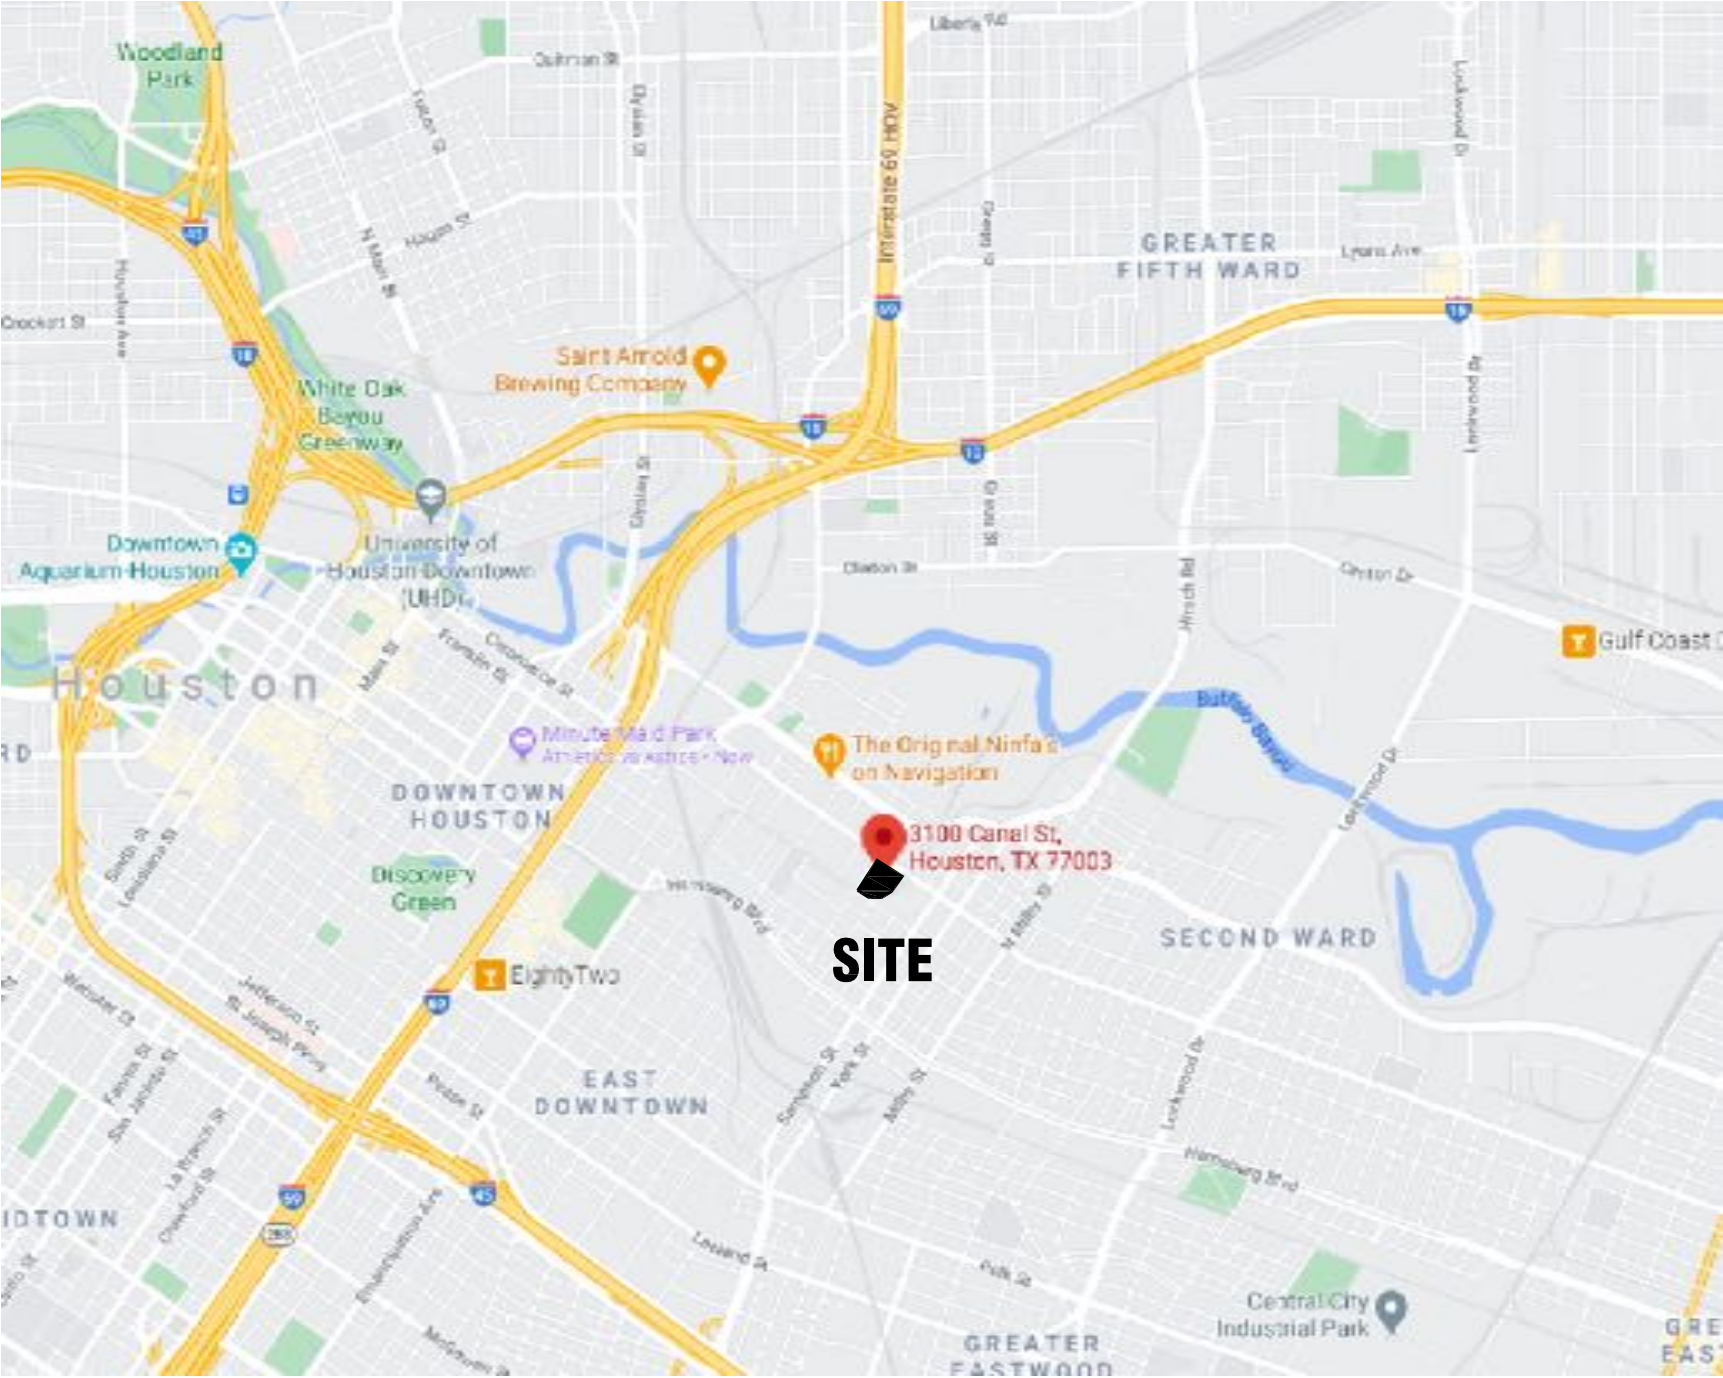


AS-BUILT DOCUMENTATION

DRAWING INDEX

- C-1 COVER SHEET | DRAWING INDEX
- SL SYMBOLS LEGEND
- AB-1 FIRST FLOOR PLAN
- AB-2 SECOND FLOOR PLAN
- AB-3 EXTERIOR ELEVATIONS

Houston TX 77003



VICINITY MAP NTS

AREA DATA	
FIRST FLOOR	55,820 S.F. ±
LOWER FIRST FLOOR	14,980 S.F. ±
SECOND FLOOR	18,982 S.F. ±
FIRST FLOOR OFFICES	1,980 S.F. ±
LOADING DOCKS	2,050 S.F. ±
GRAND TOTAL	93,812 S.F. ±

100% SUBMITTAL

As BUILT

PROFESSIONALS

AsbuiltProfessionals.com

A DIVISION OF:

AEC

CONSULTANTS INC

844.272.8458

844-ASBUILT


















© 2021 As Built Professionals

© 2021 AEC Consultants Inc.


ARCHITECTURAL AS BUILT

HOUSTON, TX 77003

01	100% SUBMISSION	SEE COVER SHEET
NO.	ISSUES REVISIONS	DATE
		SHEET TITLE
COVER SHEET		
—	PROJECT MANAGER	
—	PROJECT DIRECTOR	
— —	PROJECT NUMBER	
		SCALE
— —	DRAWN BY	
		SHEET NUMBER
C-1		

           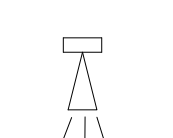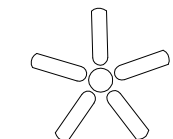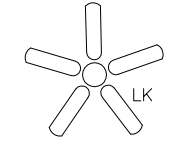   SYMBOLS LEGEND					
RCP  EXHAUST VENT  CEILING MOUNTED LIGHT FIXTURE  CEILING MOUNTED DIRECTIONAL LIGHT  RECESSED CAN LIGHT  EYEBALL OR SMALL CAN LIGHT  PENDANT LIGHT  INDIVIDUAL FLUOR. LAY-IN FIXTURE 4 BULB  INDIVIDUAL FLUOR. HANGING FIXTURE 2 BULB  INDIVIDUAL FLUOR. FLUSH MOUNT FIXTURE 4 BULB  CAMERA  MOTION DET.  SUPPLY VENT  SUPPLY VENT  RETURN VENT  RETURN VENT  SPEAKER  TRACK LIGHT OR VANITY LIGHT  WALL-MOUNTED LIGHT FIXTURE  EMERGENCY EXIT SIGN  EMERGENCY EXIT LIGHT  EMERGENCY EXIT LIGHT W/ SIGN  LIGHTED STAIR SIGN  FLOOD LIGHT  PC PHOTO CELL  CEILING FAN  CEILING FAN W/ LIGHT KIT 7-2-6 CEILING HEIGHT AND TRIM 7'-2" ABOVE FLOOR BELOW WITH 6" CROWN MOULDING. NOTE: ALL CEILINGS NOT LABELED ARE PLASTER. CEILINGS SHOWN WITH A GRID ARE LAY IN ACOUSTICAL TILE..  JUNCTION BOX		ELECTRIC  DATA OUTLET  TELEPHONE JACK  ELECTRIC SWITCH  CABLE TELEVISION OUTLET  DUPLEX RECEPTACLE OUTLET  SPECIAL PURPOSE CONNECTION OR OUTLET  QUADRUPLEX RECEPTACLE OUTLET  FLOOR DUPLEX RECEPTACLE OUTLET  ELECTRIC PANEL  ELECTRIC METER  BUTTON SWITCH  DISCONNECT SWITCH  GROUND/FLOOR LIGHT  KEY PAD		FIRE PROTECTION  FIRE EXTINGUISHER  FIRE PULL  FIRE ALARM (HORN/SRTOBE)  SMOKE DETECTOR  SMOKE ALARM SPEAKER  SPRINKLER HEAD CEILING MOUNT  SPRINKLER HEAD WALL MOUNT	
		MEP  THERMOSTAT  FLOOR DRAIN  VALVE  HOSE BIB  WATER SUPPLY  SUSPENDED GAS HEATER			
		MISC  BOLLARD  11-4-11/16 SPOT ELEVATION			


DIRECTION OF DETAIL IDENTIFYING DETAIL NAME 1 AB-5 SHEET NUMBER DETAIL IS LOCATED ON INTERIOR ELEVATIONS	IDENTIFYING DETAIL NAME AB-5 SHEET NUMBER DETAIL IS LOCATED ON BUILDING SECTION
---	--

 PHOTO DOCUMENTATION LEGEND					
INDICATES LOCATION OF CAMERA INDICATES DIRECTION OF CAMERA LENS AND CORRESPONDING PHOTO / VIDEO NUMBER TYPES OF DOCUMENTATION					
 001 GROUND BASED PHOTO	 V-001 GROUND BASED VIDEO	 000 360° SPHERICAL PHOTO	 000 AERIAL BASED PHOTO	 V-000 AERIAL BASED VIDEO	

ARCHITECTURAL AS BUILT

TX 77003

01	100% SUBMISSION	SEE COVER SHEET
NO.	ISSUES REVISIONS	DATE
SHEET TITLE		
SYMBOLS LEGEND		
		PROJECT MANAGER
		PROJECT DIRECTOR
---		PROJECT NUMBER
NOT TO SCALE		SCALE
--		DRAWN BY
SHEET NUMBER		
SL		

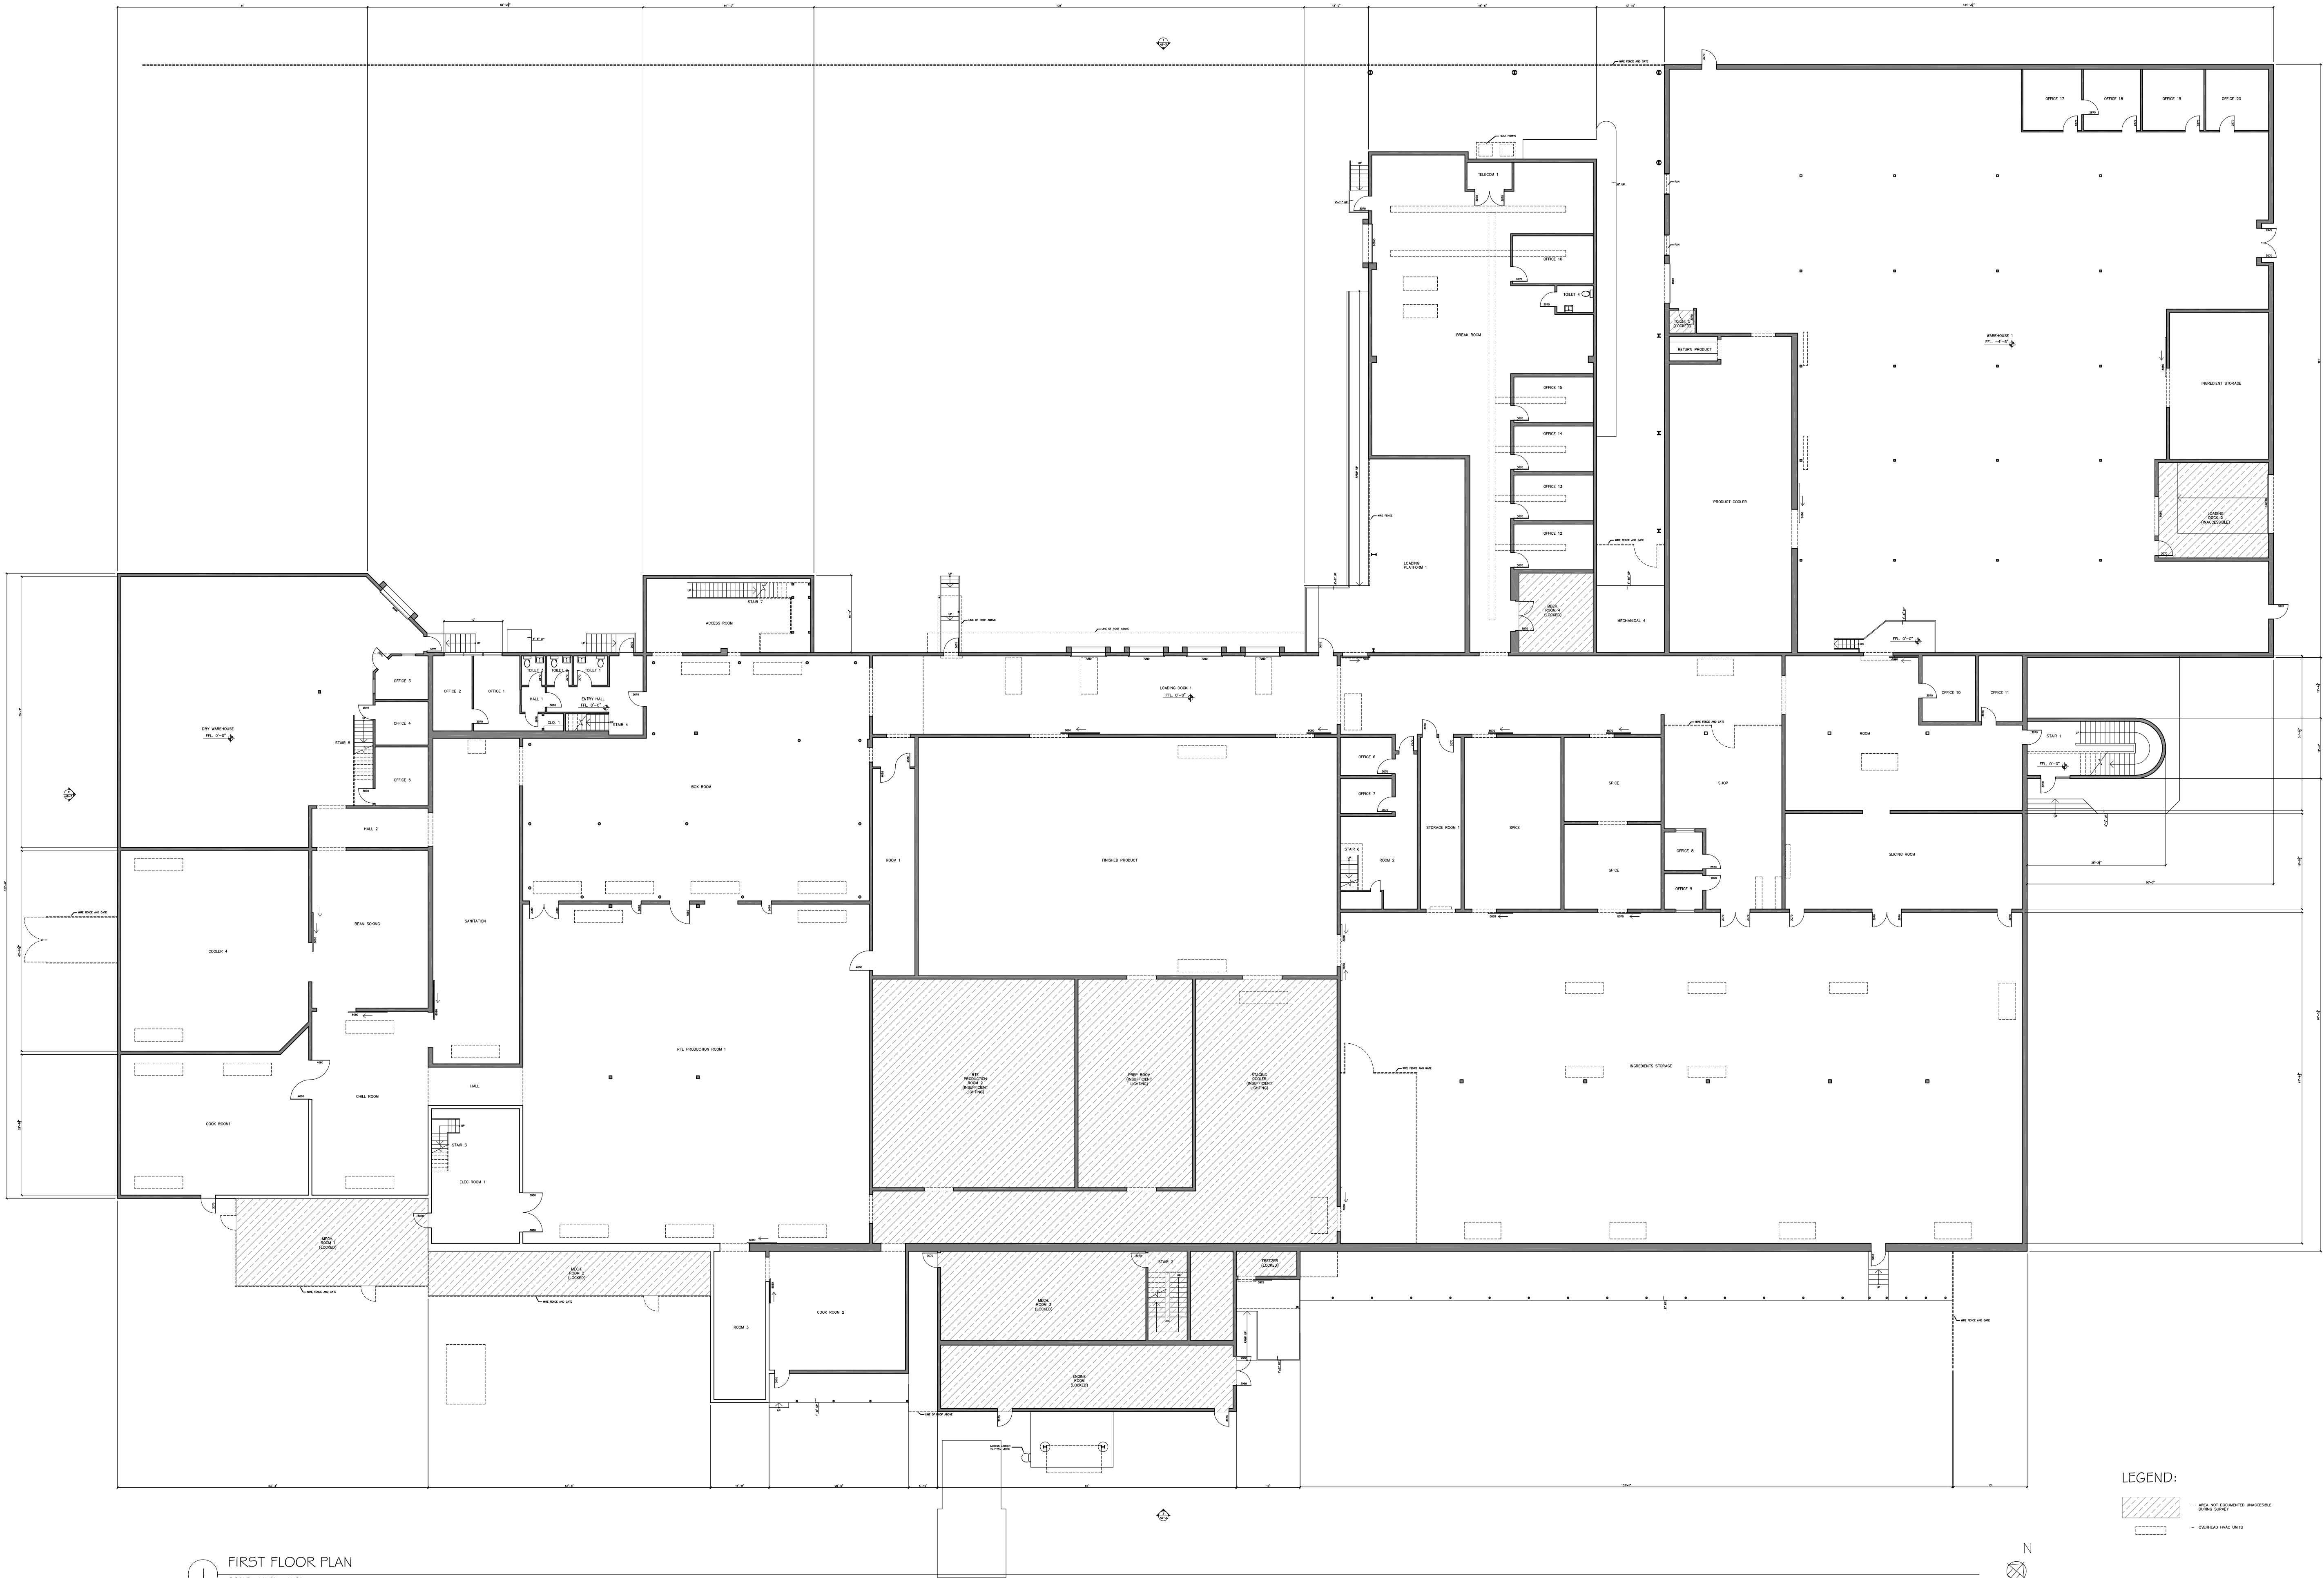

As BUILT

PROFESSIONALS

AsbuiltProfessionals.com

A DIVISION OF:

AEC

CONSULTANTS INC

844.272.8458

844-ASBUILT

© 2021 As Built Professionals


© 2021 AEC Consultants Inc.

ARCHITECTURAL AS BUILT

HOUSTON, TX 77003


01	100% SUBMISSION	SEE COVER SHEET
NO.	ISSUES REVISIONS	DATE
		SHEET TITLE
		FIRST FLOOR PLAN
		PROJECT MANAGER
		PROJECT DIRECTOR
		PROJECT NUMBER
		SCALE
		DRAWN BY
		SHEET NUMBER

 AB-1




HOUSTON, TX 77003

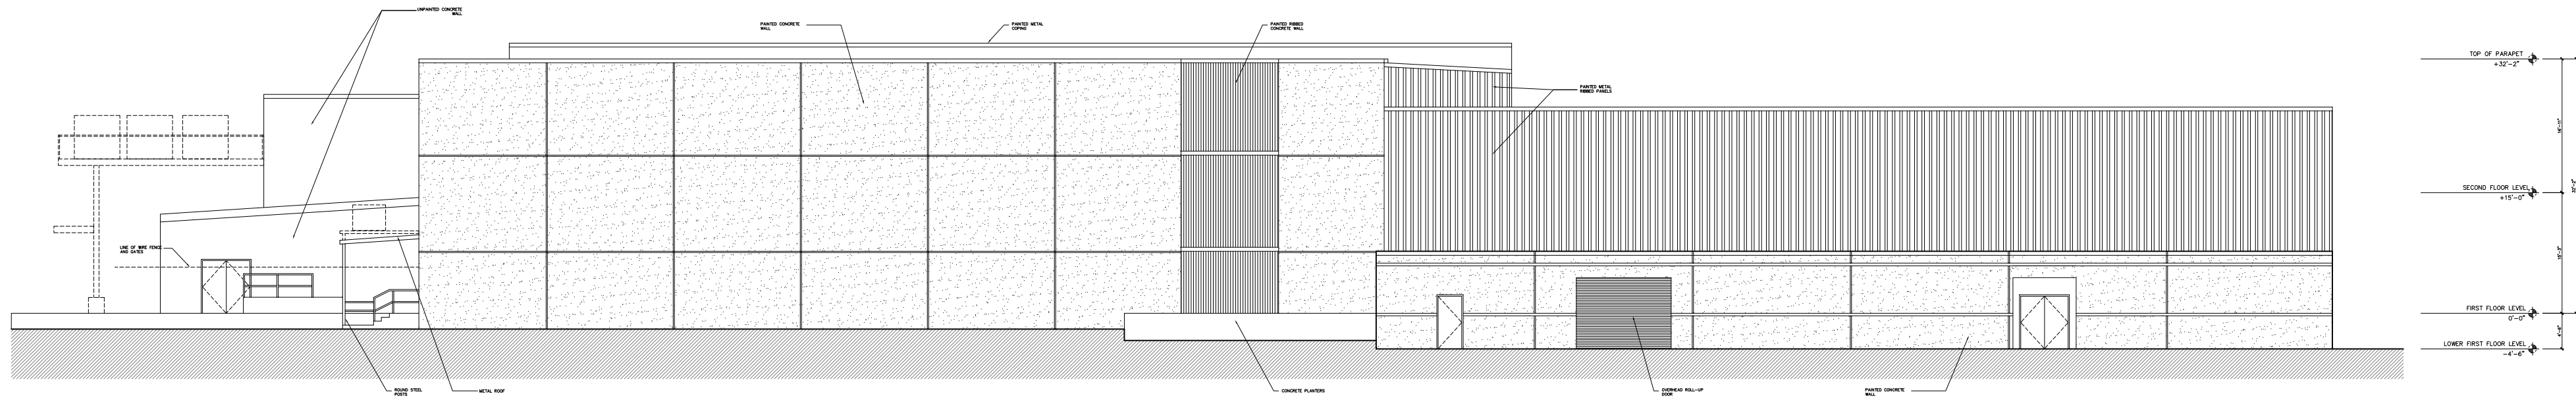
SHEET NUMBER



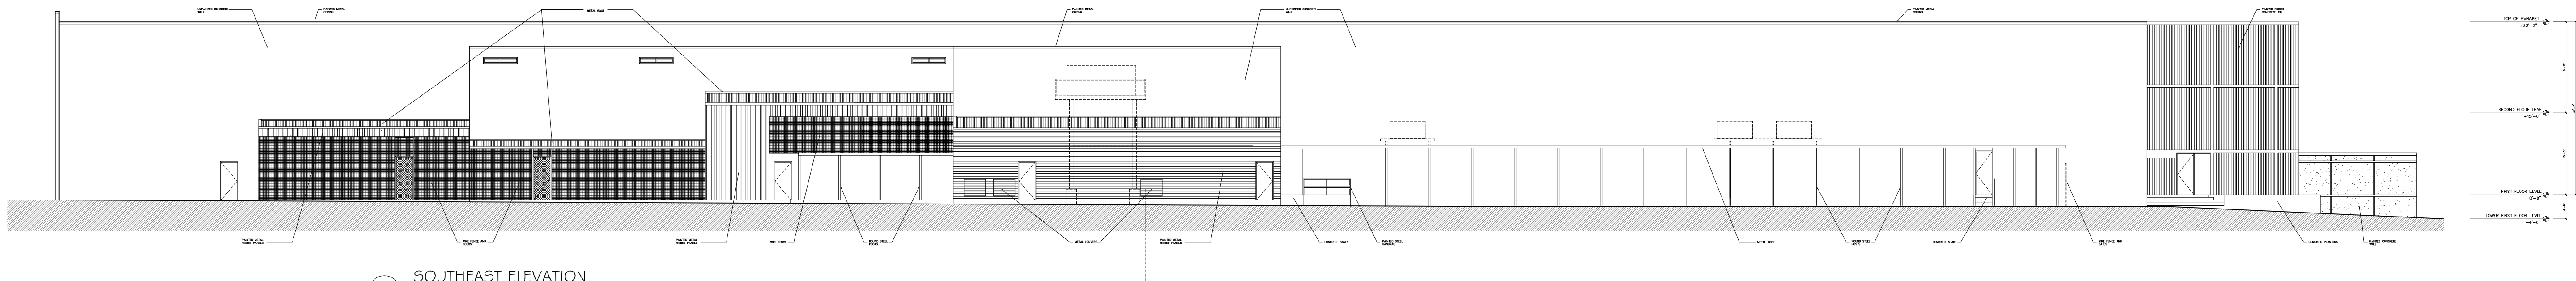
4 NORTHEAST ELEVATION
SCALE: 1/16" = 1'-0"



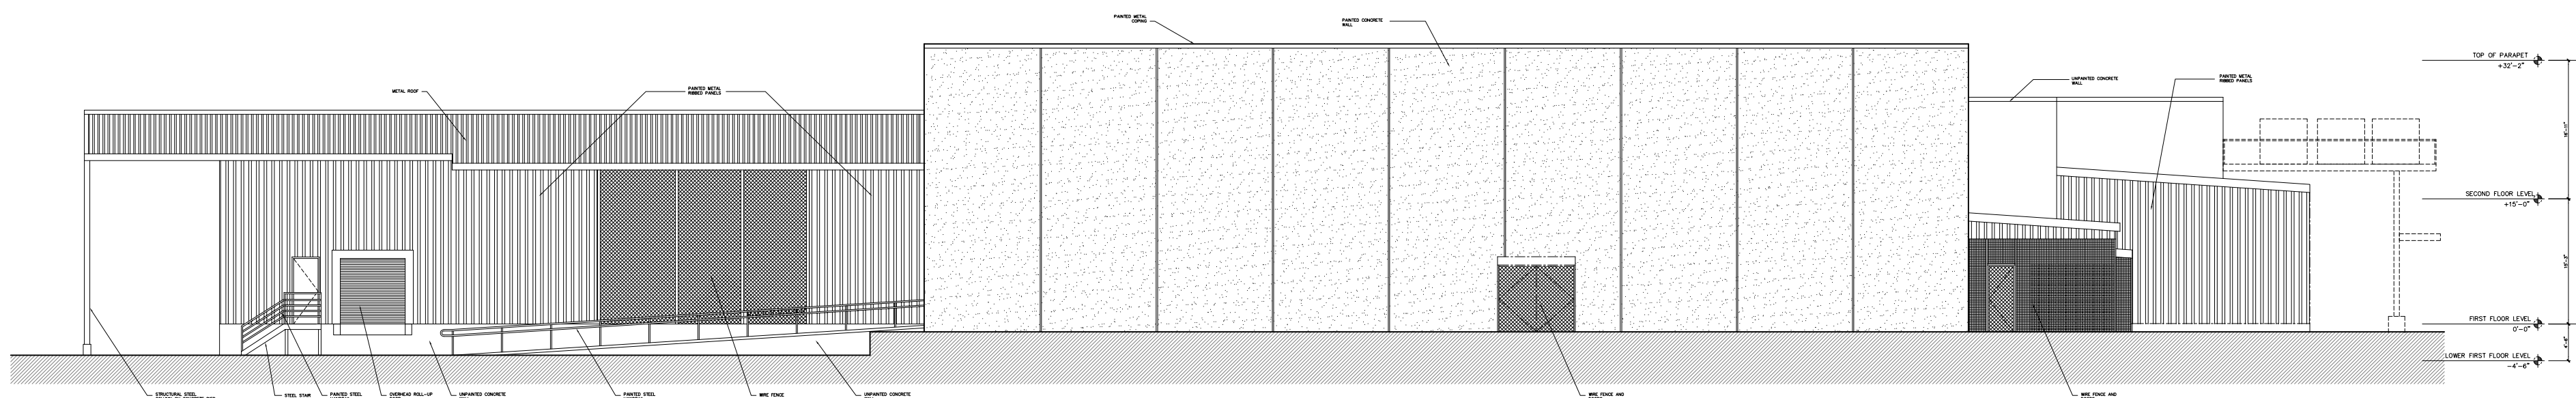3 SOUTHEAST ELEVATION
SCALE: 1/16" = 1'-0"



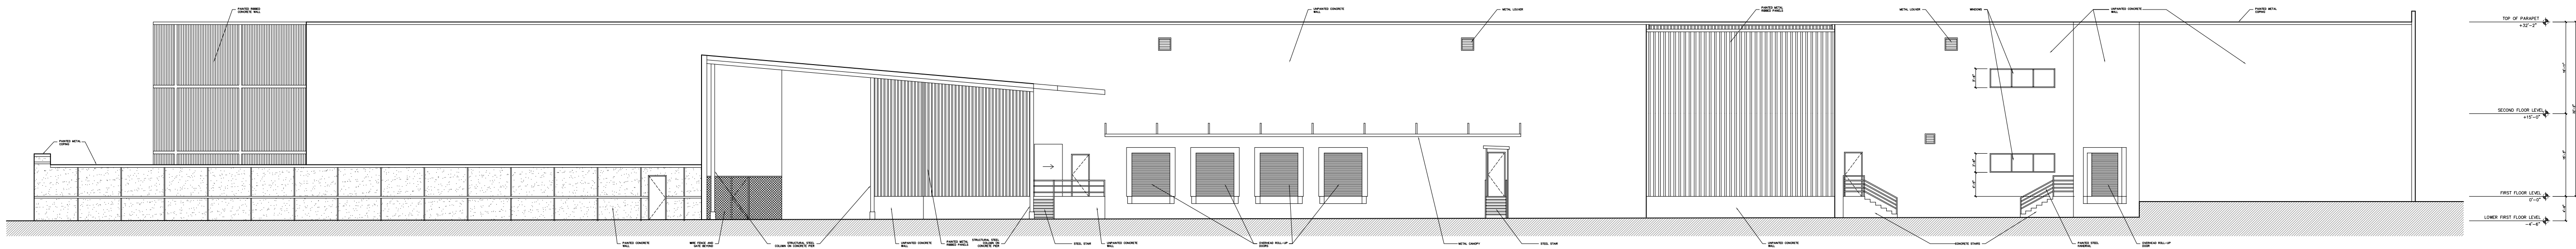2 SOUTHWEST ELEVATION
SCALE: 1/16" = 1'-0"



1 NORTHWEST ELEVATION
SCALE: 1/16" = 1'-0"

As BUILT

PROFESSIONALS

AsbuiltProfessionals.com

A DIVISION OF:

AEC

CONSULTANTS INC

844.272.8458

844-ASBUILT

© 2021 As Built Professionals

© 2021 AEC Consultants Inc.

ARCHITECTURAL AS BUILT

HOUSTON, TX 77003

01	100% SUBMISSION	SEE COVER SHEET
NO.	ISSUES REVISIONS	DATE

EXTERIOR ELEVATIONS

PROJECT MANAGER
PROJECT DIRECTOR
PROJECT NUMBER
SCALE
DRAWN BY
SHEET NUMBER

1'-16"=1'-0"

AB-3