

AS-BUILT DOCUMENTATION

Meadows Apartments

Louisville, KY 40220

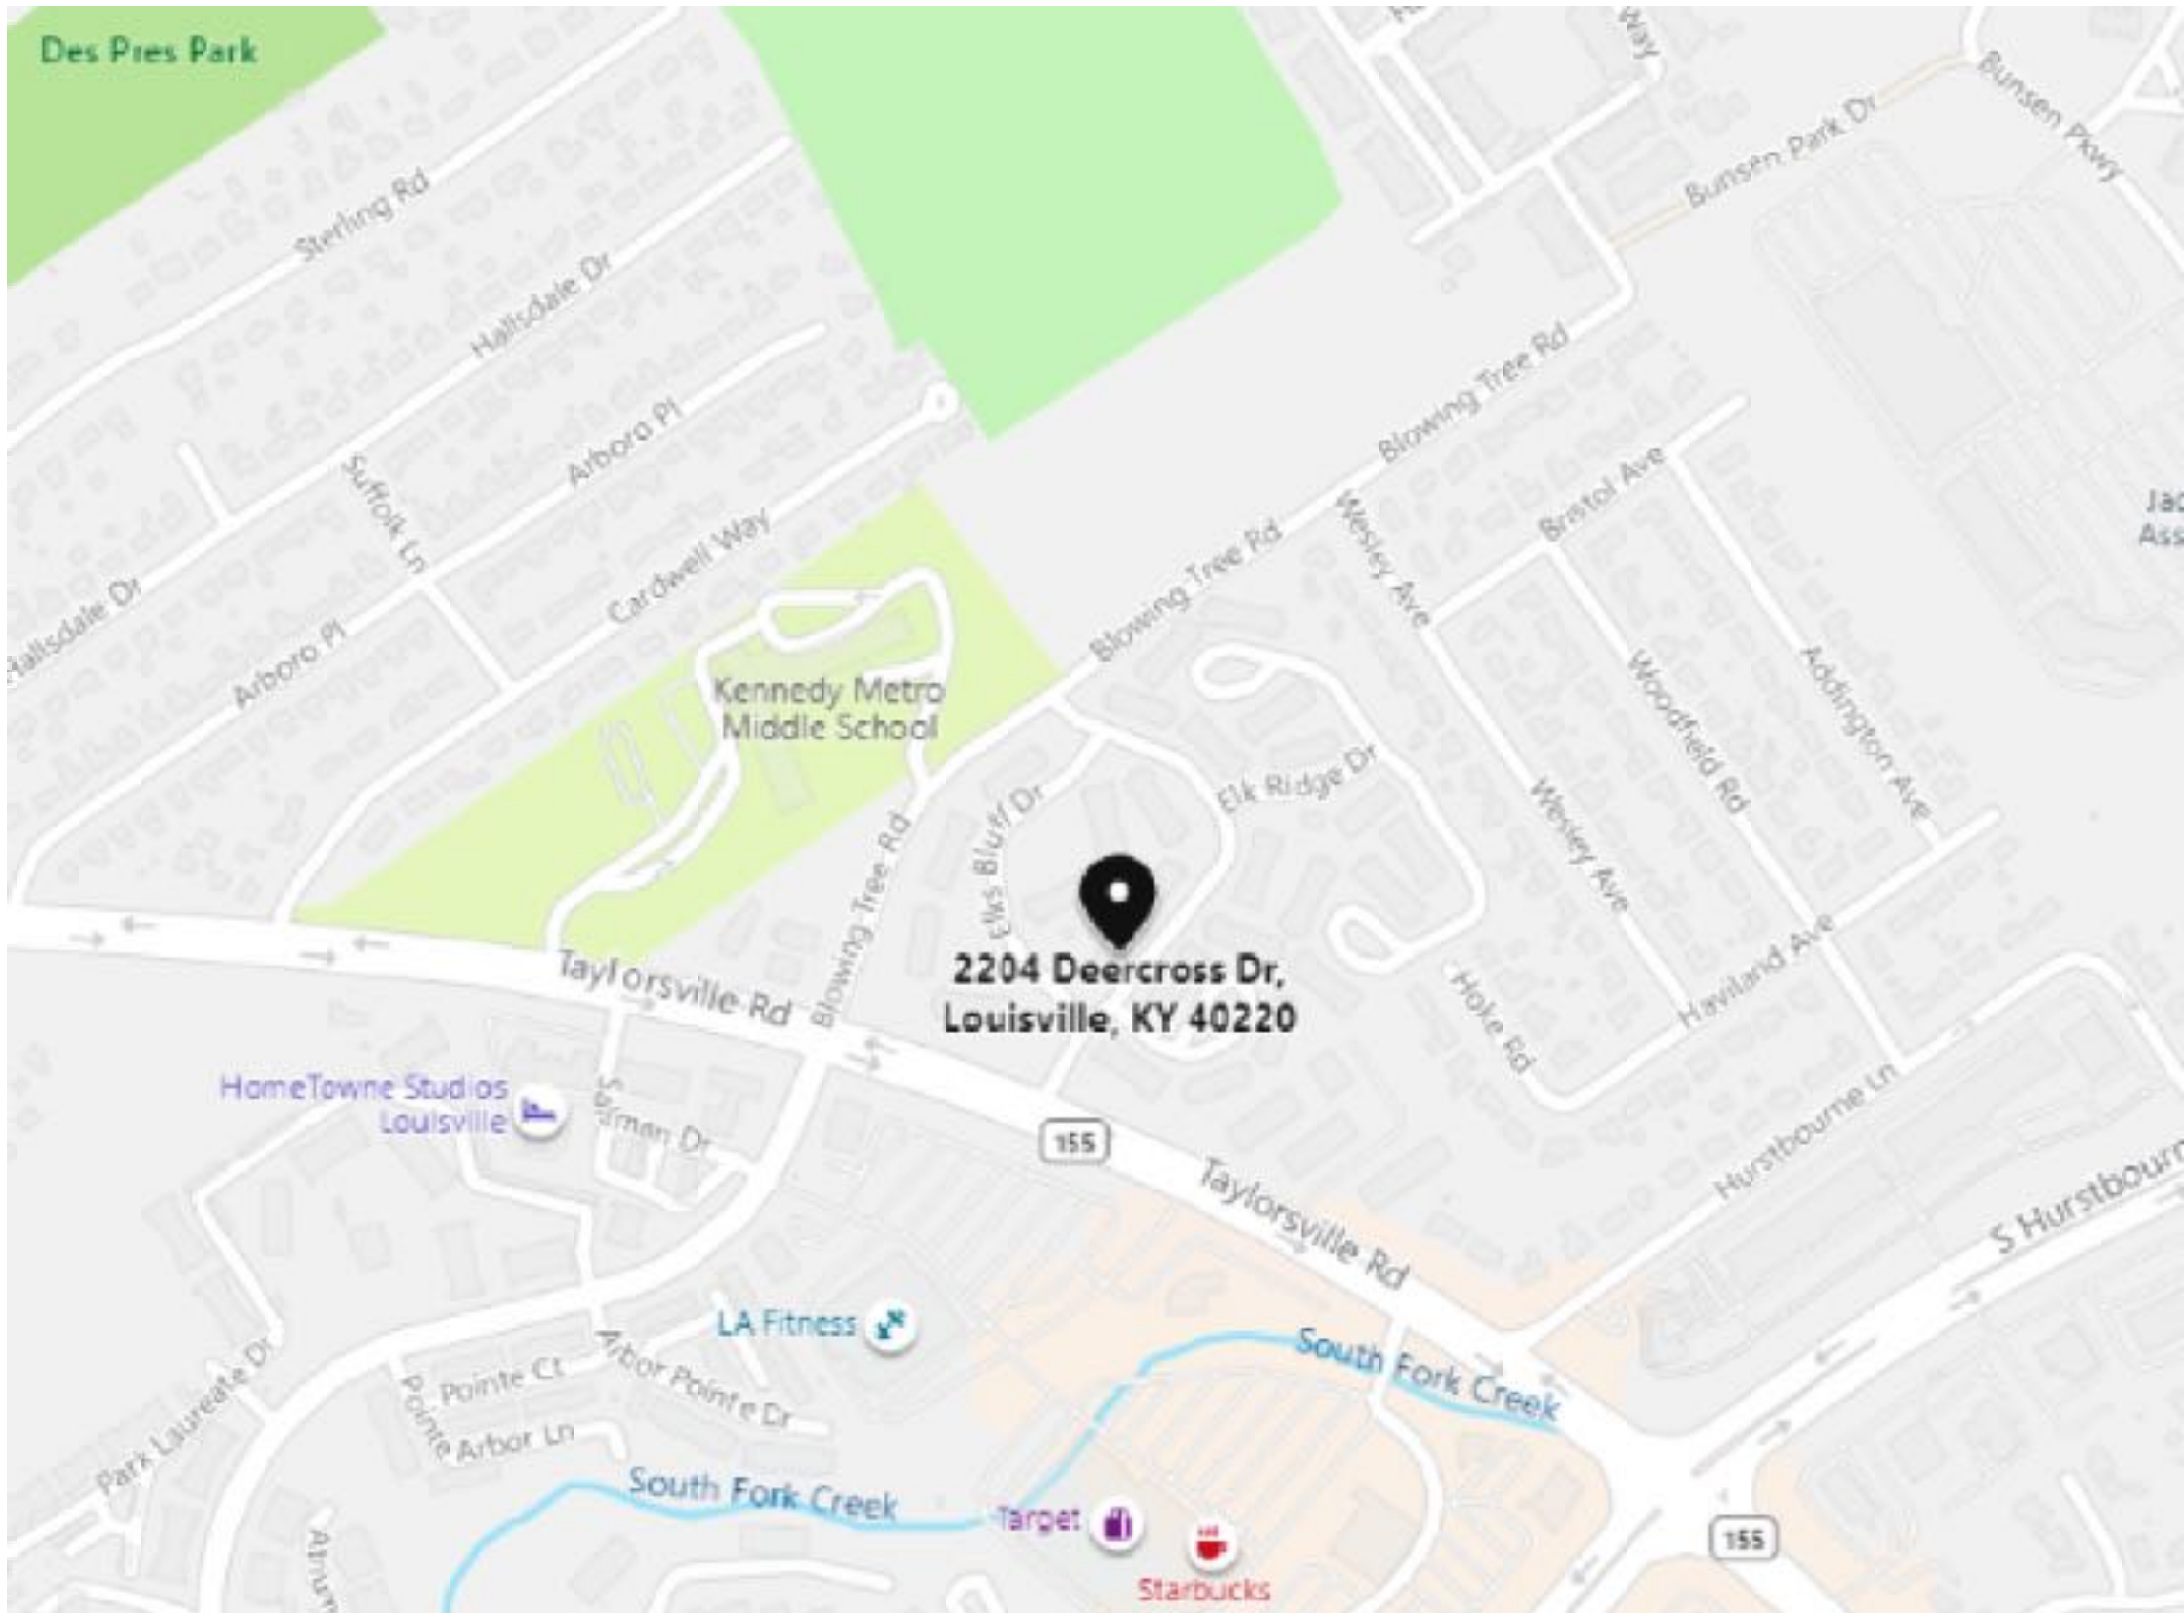


100% SUBMITTAL

****Scope of work Checklist includes:** Floor Plans, RCP Plans, MEP Plans, Selected Interior Elevations, Selected Site Plans, Feature Attribute Schedule, Window Schedule, Cabinet Schedule.

DRAWING INDEX

C-1	COVER SHEET DRAWING INDEX
SL	SYMBOLS LEGEND
AB-1	UNIT 11-102
AB-2	UNIT 11-200
AB-3	UNIT 22-103
AB-4	UNIT 20-200
AB-5	UNIT 22-101
AB-6	UNIT 24-106
AB-7	SITE PLAN
AB-8	INTERIOR ELEVATIONS 1
AB-9	INTERIOR ELEVATIONS 2
AB-10	SCHEDULES



VICINITY MAP
NTS

AREA DATA	
UNIT 11-102	682 S.F. ±
UNIT 11-200	534 S.F. ±
UNIT 22-103	682 S.F. ±
UNIT 20-200	847 S.F. ±
UNIT 22-101	865 S.F. ±
UNIT 24-106	916 S.F. ±
GRAND TOTAL	4,526 S.F. ±

As BUILT

PROFESSIONALS

www.asbuiltprofessionals.com

A DIVISION OF:

AEC

CONSULTANTS INC

844.272.8458

844 A S BUILT

© 2021 AEC CONSULTANTS INC












ARCHITECTURAL AS BUILT
Meadows Apartments
Louisville, KY 40220









01	ISSUES REVISIONS	DATE	SHEET TITLE
COVER SHEET			
HL	PROJECT MANAGER		
HL	PROJECT DIRECTOR		
012317-1	PROJECT NUMBER		
	SCALE		
BB	DRAWN BY		
	SHEET NUMBER		

C-1

SYMBOLS LEGEND

           RCP






-  EXHAUST VENT
-  CEILING MOUNTED LIGHT FIXTURE
-  CEILING MOUNTED DIRECTIONAL LIGHT
-  RECESSED CAN LIGHT
-  EYEBALL OR SMALL CAN LIGHT
-  PENDANT LIGHT
-  INDIVIDUAL FLUOR. LAY-IN FIXTURE 4 BULB
-  INDIVIDUAL FLUOR. HANGING FIXTURE 2 BULB
-  INDIVIDUAL FLUOR. FLUSH MOUNT FIXTURE 4 BULB
-  CAMERA
-  BLANK CEILING PLATE MOTION DET.
-  WALL MOUNT VENT
-  SUPPLY VENT
-  SUPPLY VENT
-  RETURN VENT
-  RETURN VENT
-  SPEAKER

        -  TRACK LIGHT OR VANITY LIGHT
-  WALL-MOUNTED LIGHT FIXTURE
-  EMERGENCY EXIT SIGN
-  EMERGENCY EXIT LIGHT
-  EMERGENCY EXIT LIGHT W/ SIGN
-  LIGHTED STAIR SIGN
-  FLOOD LIGHT
-  PHOTO CELL
-  CEILING FAN
-  CEILING FAN W/ LIGHT KIT
-  JUNCTION BOX



7-2-6 CEILING HEIGHT AND TRIM 7'-2" ABOVE FLOOR BELOW WITH 6" CROWN MOULDING. NOTE: ALL CEILINGS NOT LABELED ARE PLASTER. CEILINGS SHOWN WITH A GRID ARE LAY IN ACOUSTICAL TILE..

JUNCTION BOX

     
ELECTRIC

-  DATA OUTLET
-  TELEPHONE JACK
-  ELECTRIC SWITCH
-  CABLE TELEVISION OUTLET
-  BLANK PLATE
-  FLOOR OUTLET
-  DUPLEX RECEPTACLE OUTLET
-  SPECIAL PURPOSE CONNECTION OR OUTLET
-  QUADRUPLX RECEPTACLE OUTLET
-  CEILING RECEPTACLE OUTLET
-  WI-FI/DATA BOX
-  ELECTRIC PANEL
-  ELECTRIC METER
-  MOTION SENSOR
-  BUTTON SWITCH
-  DISCONNECT SWITCH
-  WALL MOUNT EXHAUST VENT
-  GROUND/FLOOR LIGHT
-  BASEBOARD HEAT
-  KEY PAD


 
 
FIRE PROTECTION

-  FIRE EXTINGUISHER
-  FIRE PULL
-  FIRE ALARM (HORN/SRTOBE)
-  SMOKE DETECTOR
-  SMOKE ALARM SPEAKER
-  SPRINKLER HEAD CEILING MOUNT
-  SPRINKLER HEAD WALL MOUNT

 MEP


-  THERMOSTAT
-  FLOOR DRAIN
-  VALVE
-  HOSE BIB
-  WATER SUPPLY
-  SUSPENDED GAS HEATER

   MISC


-  CABINET SCHEDULE LABEL
-  WINDOW SCHEDULE LABEL
-  BOLLARD
-  11-4-11/16 SPOT ELEVATION

7-2-6

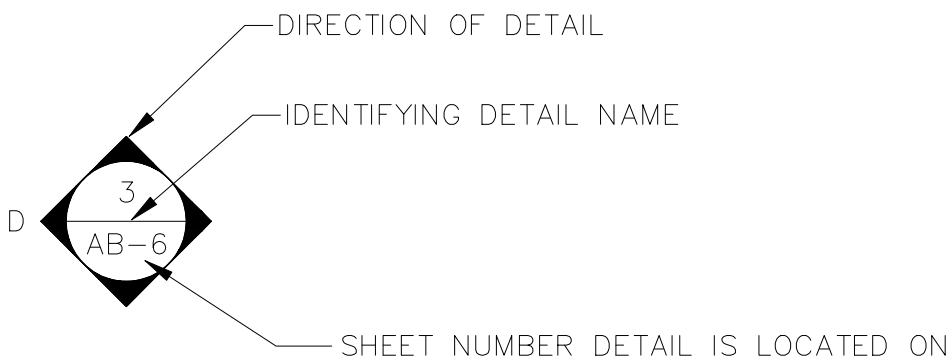
CEILING HEIGHT AND TRIM 7'-2" ABOVE FLOOR BELOW WITH 6" CROWN MOULDING. NOTE: ALL CEILINGS NOT LABELED ARE PLASTER. CEILINGS SHOWN WITH A GRID ARE LAY IN ACOUSTICAL TILE..



INTERIOR ELEVATIONS

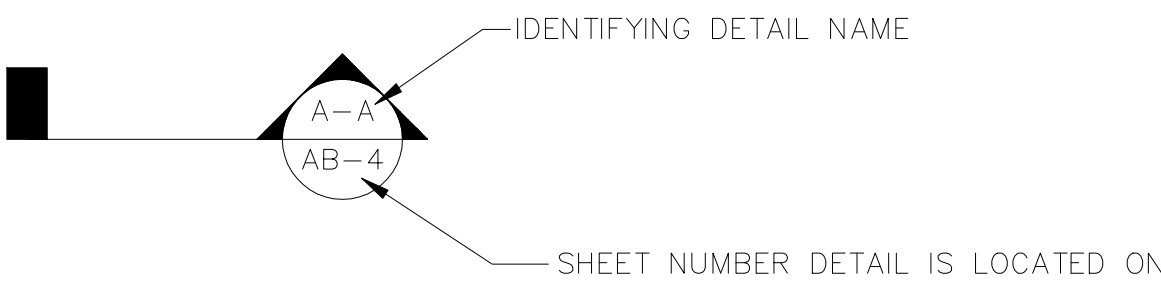

BUILDING SECTIONS

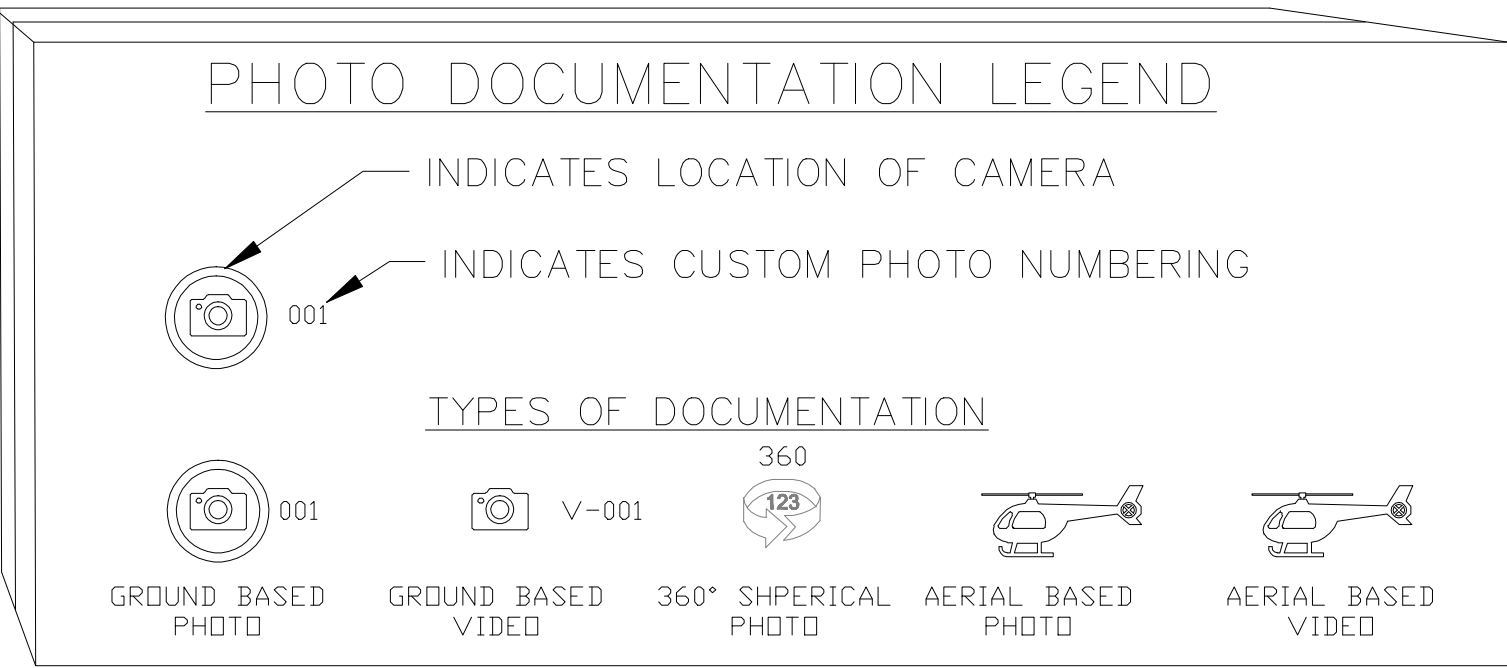



As BUILT
PROFESSIONALS
www.asbuiltprofessionals.com
A DIVISION OF:



AEC
CONSULTANTS INC
844.272.8458
844 A S BUILT


© 2021 AEC CONSULTANTS INC

ARCHITECTURAL AS BUILT
Meadows Apartments
Louisville, KY 40220

SYMBOLS LEGEND

HL	PROJECT MANAGER
HL	PROJECT DIRECTOR
012317-1	PROJECT NUMBER
NOT TO SCALE	SCALE
BB	DRAWN BY
	SHEET NUMBER

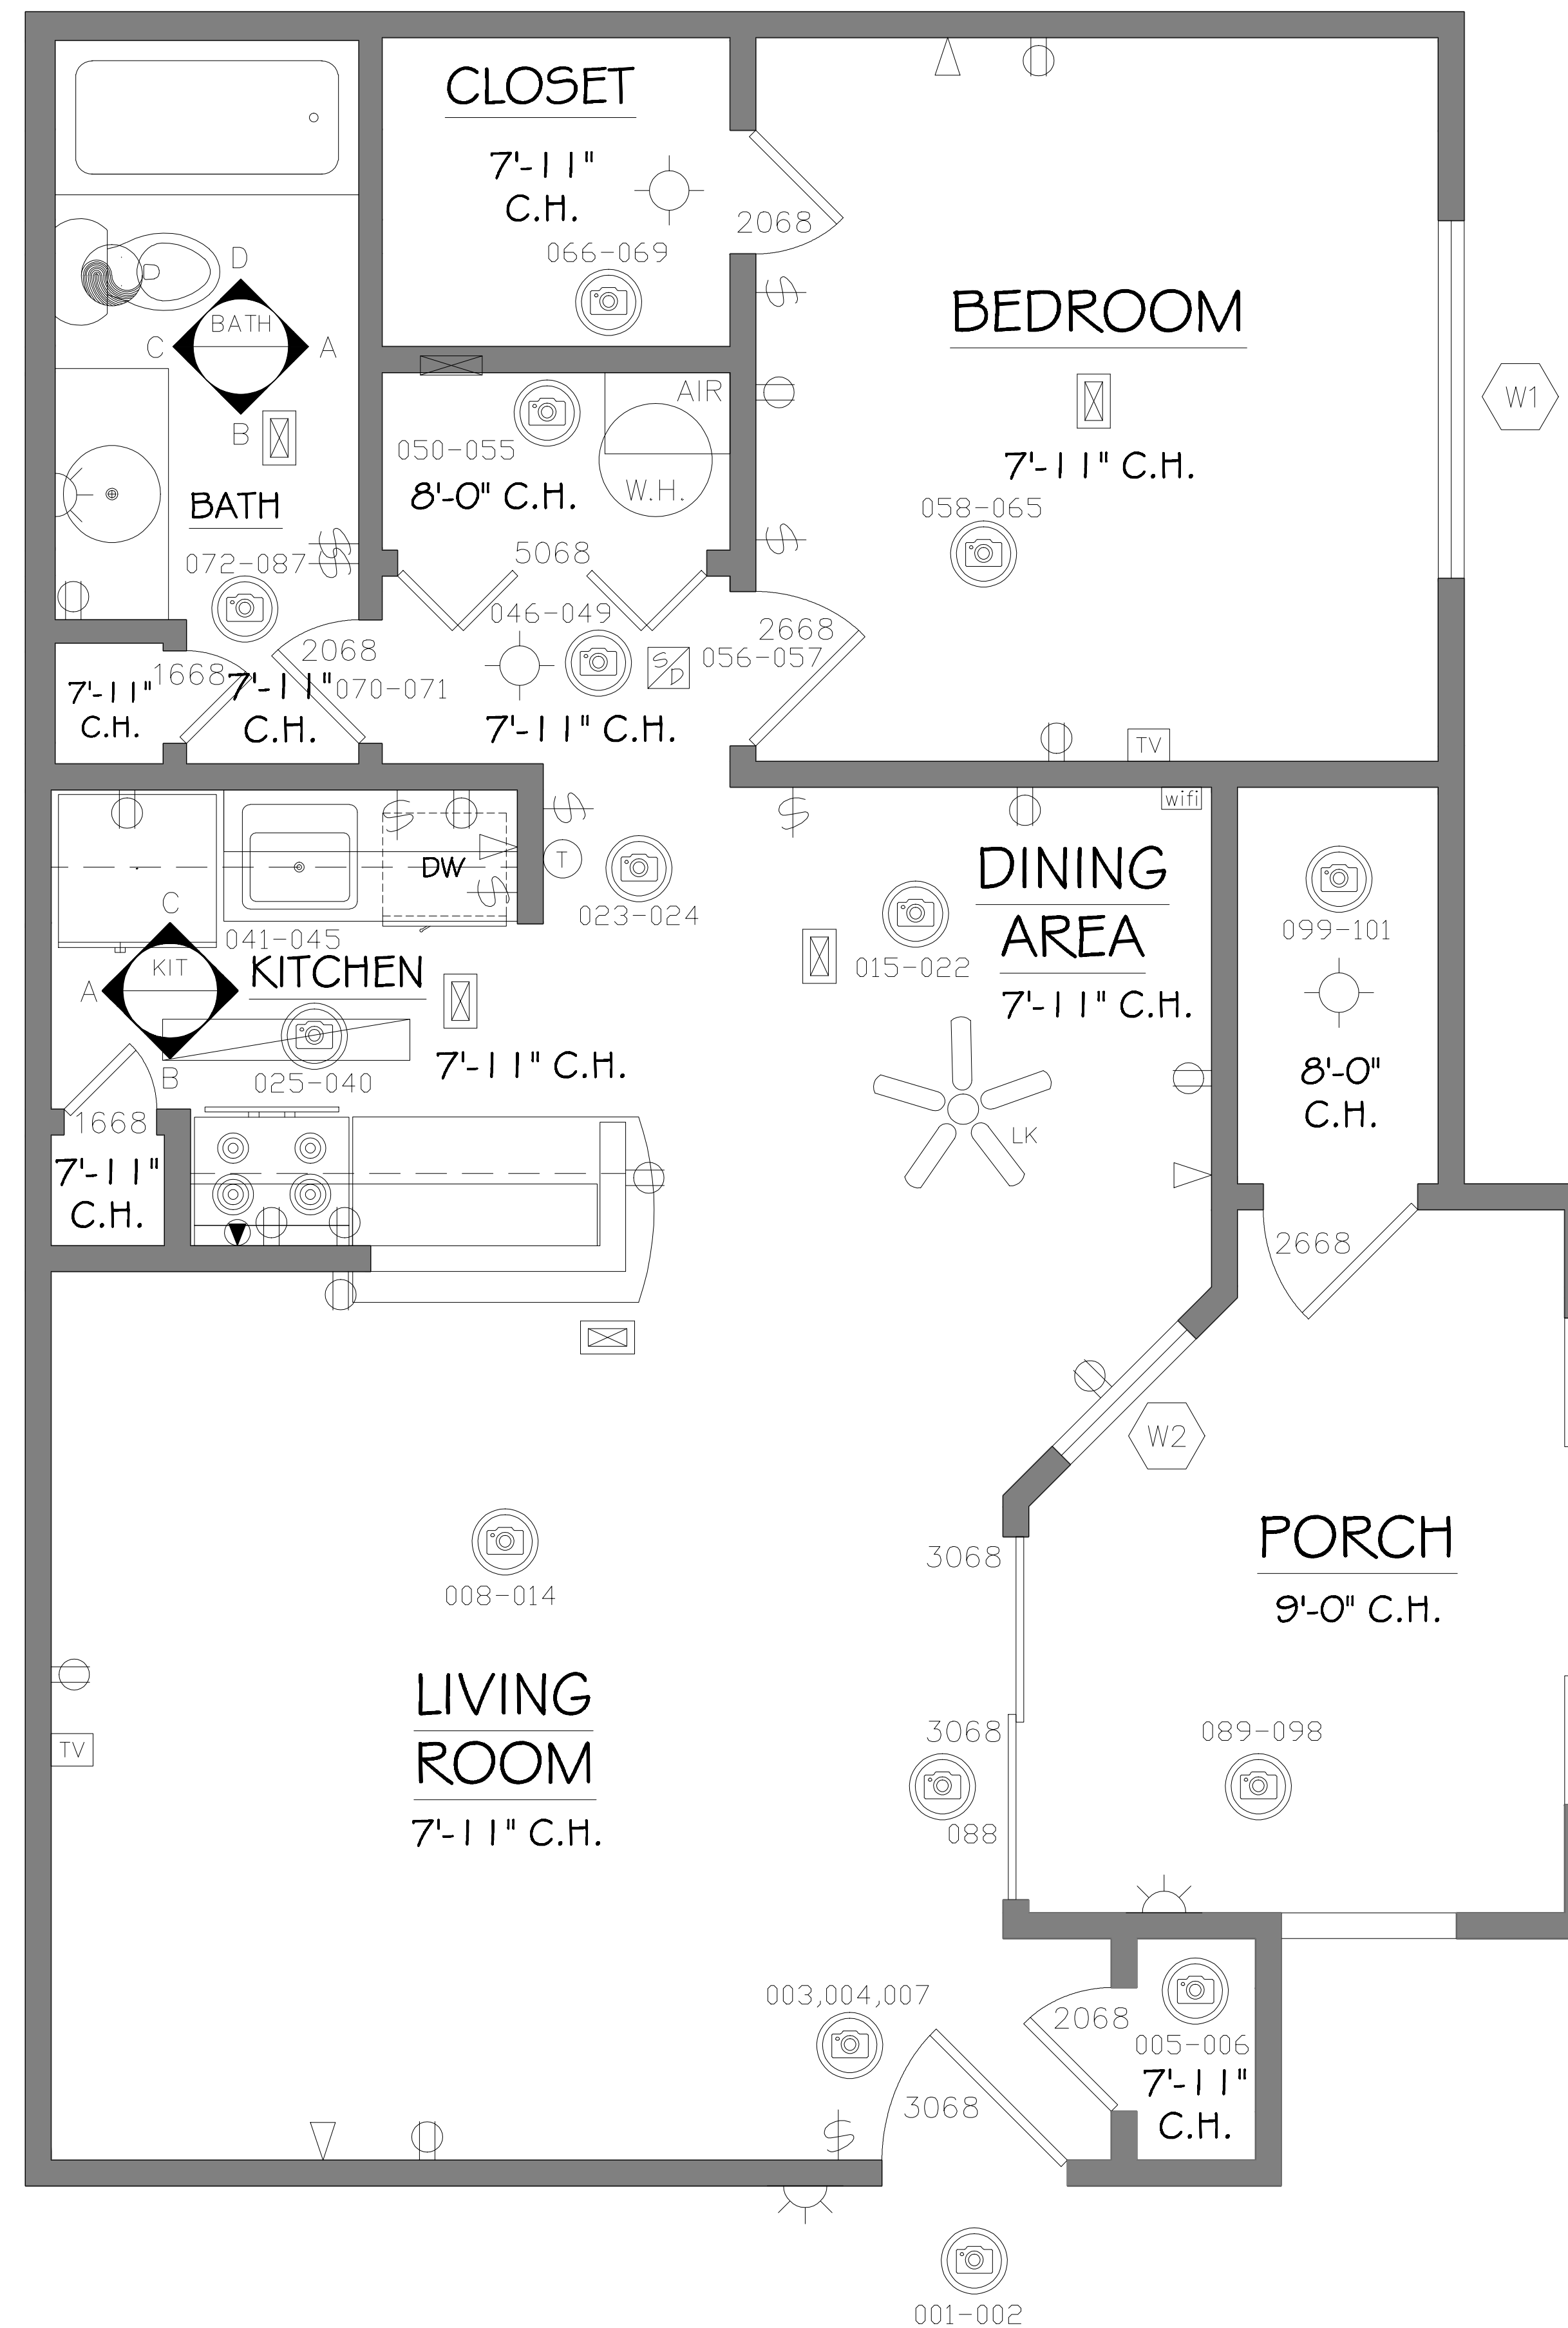SL



PLAN VIEW - 11-102

MEP ITEM COUNT	
ITEM	Total Count
Outlets	15
Phone Jacks	4
Data Ports	0
Cable Jacks	2
Switches	9
Dryer Outlet	0
Range Outlet	1


****Scope of work Checklist includes: Floor Plans, RCP Plans, MEP Plans, Selected Interior Elevations, Selected Site Plans, Feature Attribute Schedule, Window Schedule, Cabinet Schedule.**

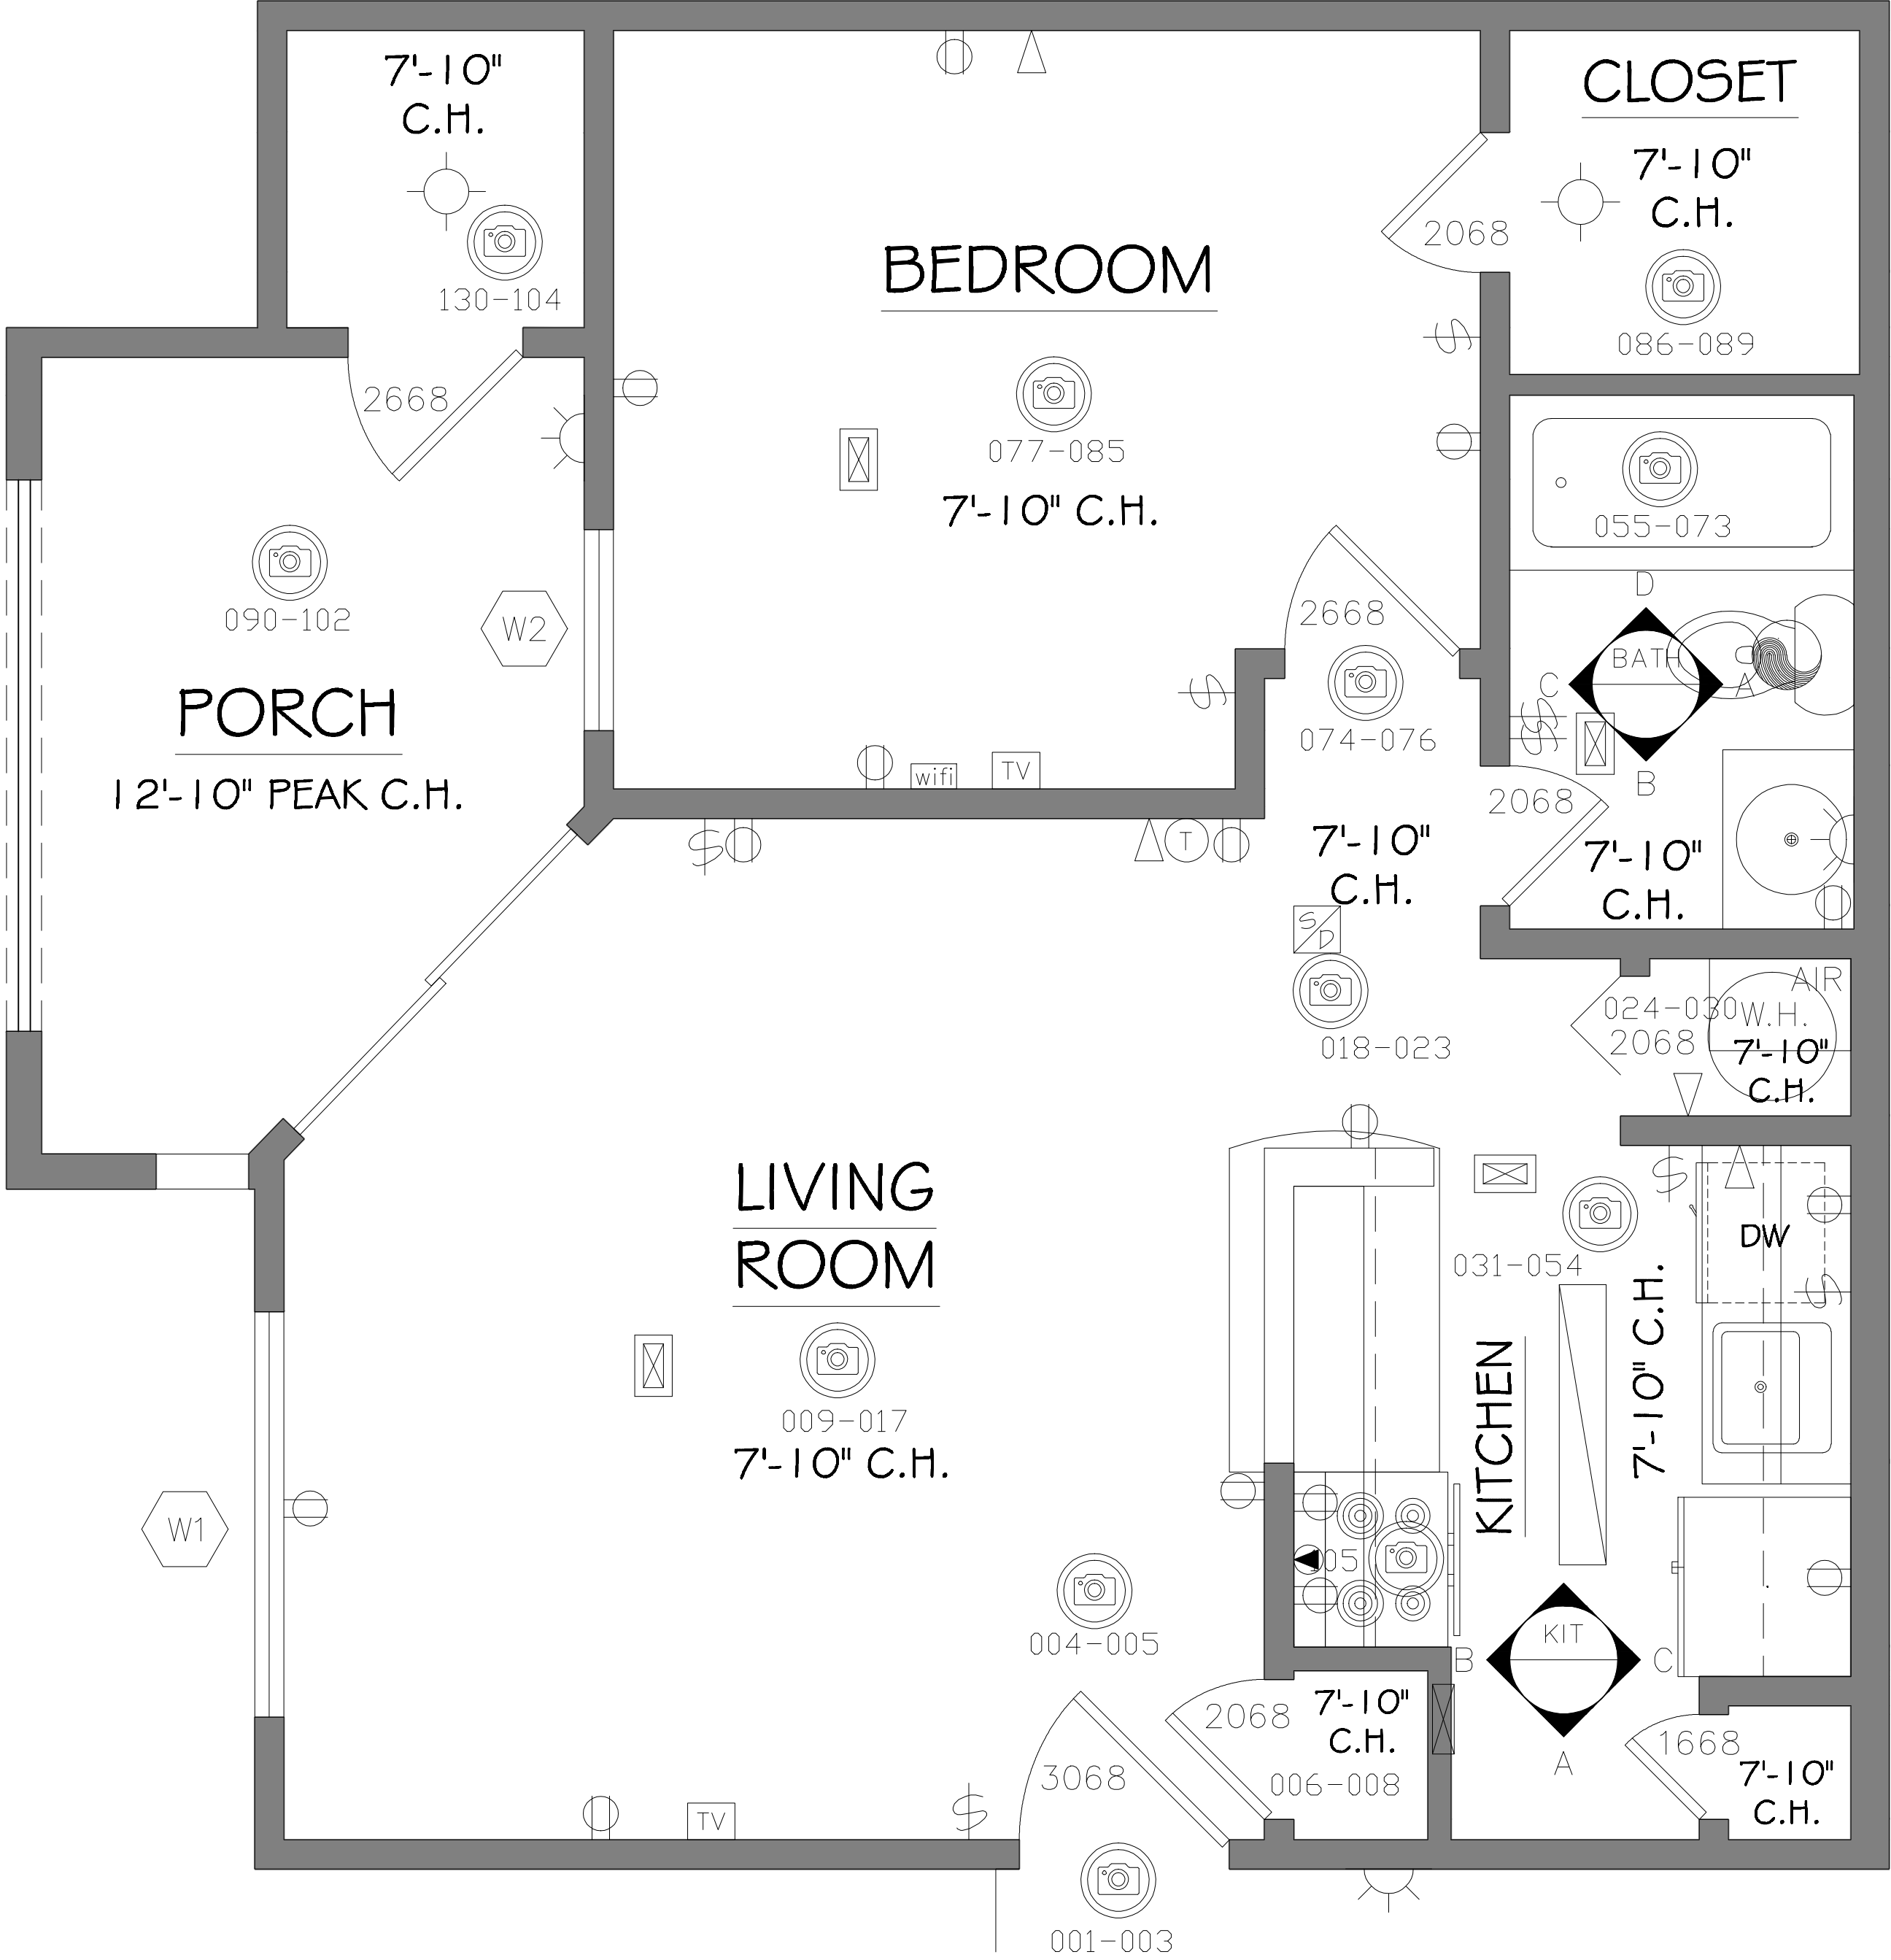ARCHITECTURAL AS BUILT
Meadows Apartments
Louisville, KY 40220

01		
NO.	ISSUES REVISIONS	DATE
		SHEET TITLE
UNIT 11-102		
HL		PROJECT MANAGER
HL		PROJECT DIRECTOR
012317-1		PROJECT NUMBER
1/2"=1'-0"		SCALE
BB		DRAWN BY
		SHEET NUMBER
AB-1		

MEP ITEM COUNT

ITEM	Total Count
Outlets	15
Phone Jacks	4
Data Ports	0
Cable Jacks	2
Switches	8
Dryer Outlet	0
Range Outlet	1



PLAN VIEW - 11-200

As BUILT

PROFESSIONALS

www.asbuiltprofessionals.com

A DIVISION OF:

AEC

CONSULTANTS INC


844.272.8458

844 AS BUILT

© 2021 AEC CONSULTANTS INC

ARCHITECTURAL AS BUILT
Meadows Apartments
Louisville, KY 40220

01	NO.	ISSUES REVISIONS	DATE	SHEET TITLE
UNIT 11-200				
HL	PROJECT MANAGER			
HL	PROJECT DIRECTOR			
012317-1	PROJECT NUMBER			
1/2"=1'-0"	SCALE			
BB	DRAWN BY			
				SHEET NUMBER
AB-2				

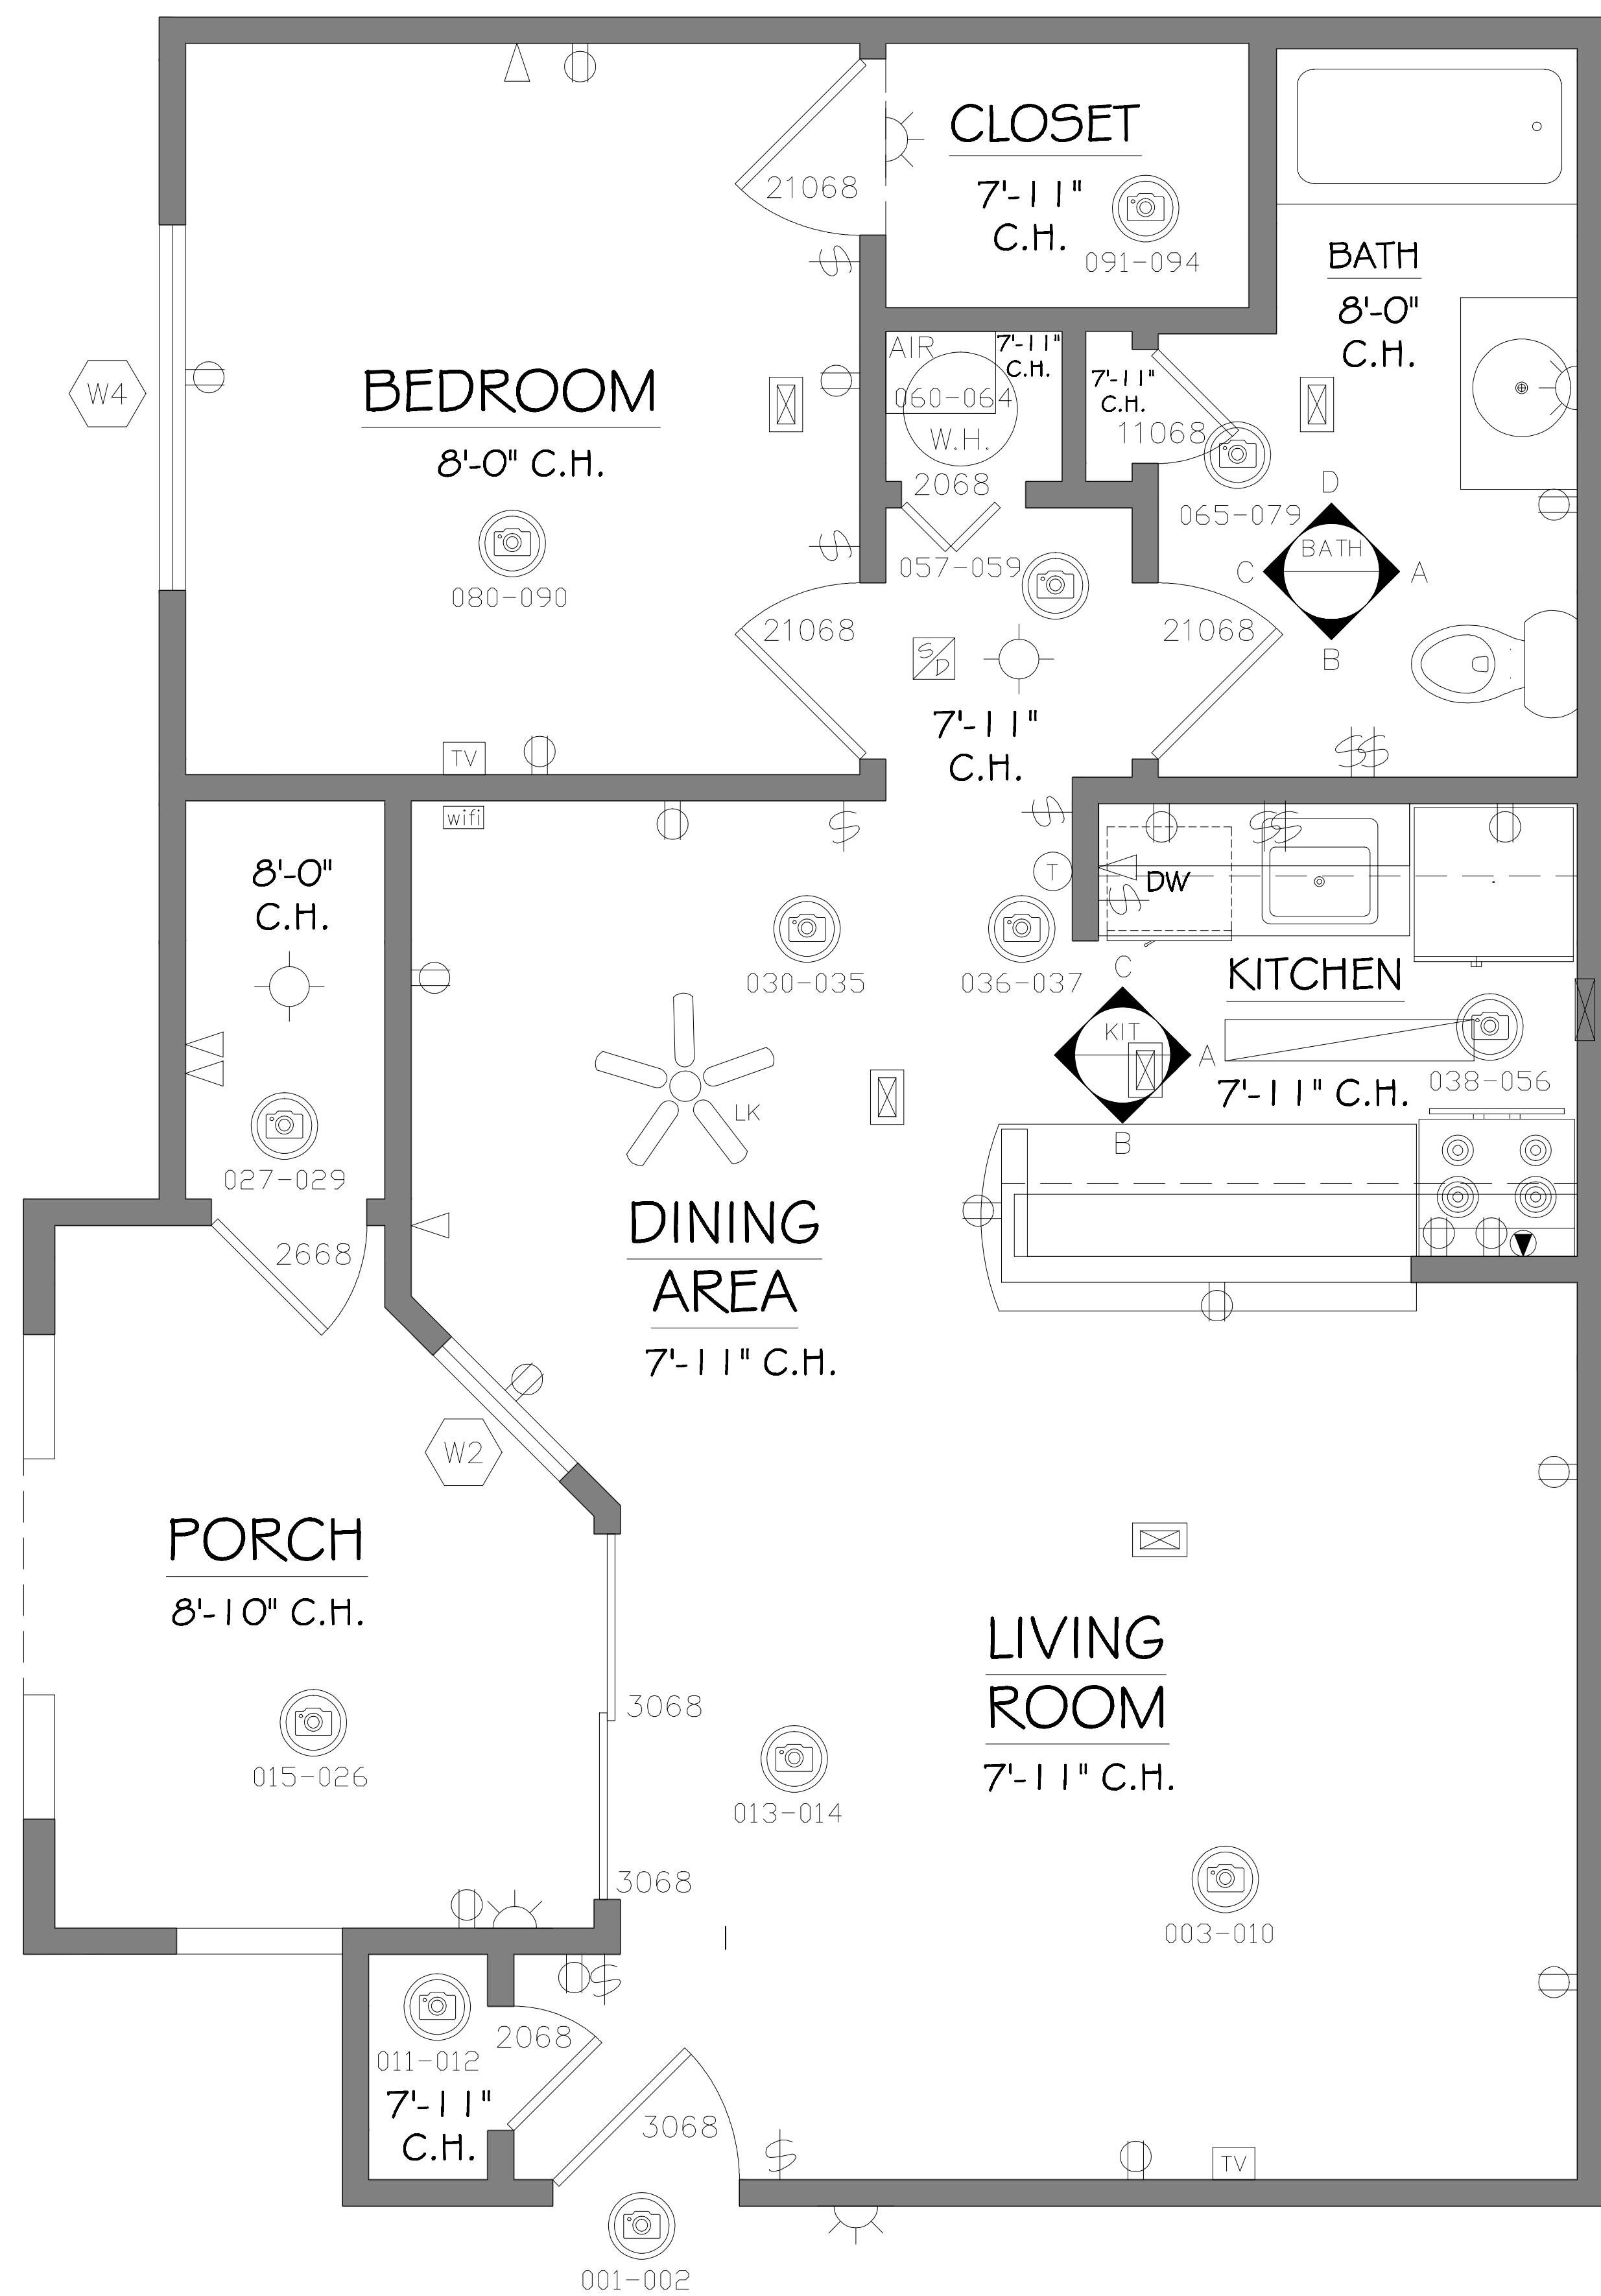

PLAN VIEW - 22-103

MEP ITEM COUNT

ITEM	Total Count
Outlets	19
Phone Jacks	5
Data Ports	0
Cable Jacks	2
Switches	10
Dryer Outlet	0
Range Outlet	1

ARCHITECTURAL AS BUILT
Meadows Apartments
Louisville, KY 40220

01		
NO.	ISSUES REVISIONS	DATE
SHEET TITLE		


UNIT 22-103

HL	PROJECT MANAGER
HL	PROJECT DIRECTOR
012317-1	PROJECT NUMBER
1/2"=1'-0"	SCALE
BB	DRAWN BY
SHEET NUMBER	

AB-3

MEP ITEM COUNT

ITEM	Total Count
Outlets	23
Phone Jacks	5
Data Ports	0
Cable Jacks	3
Switches	15
Dryer Outlet	1
Range Outlet	1

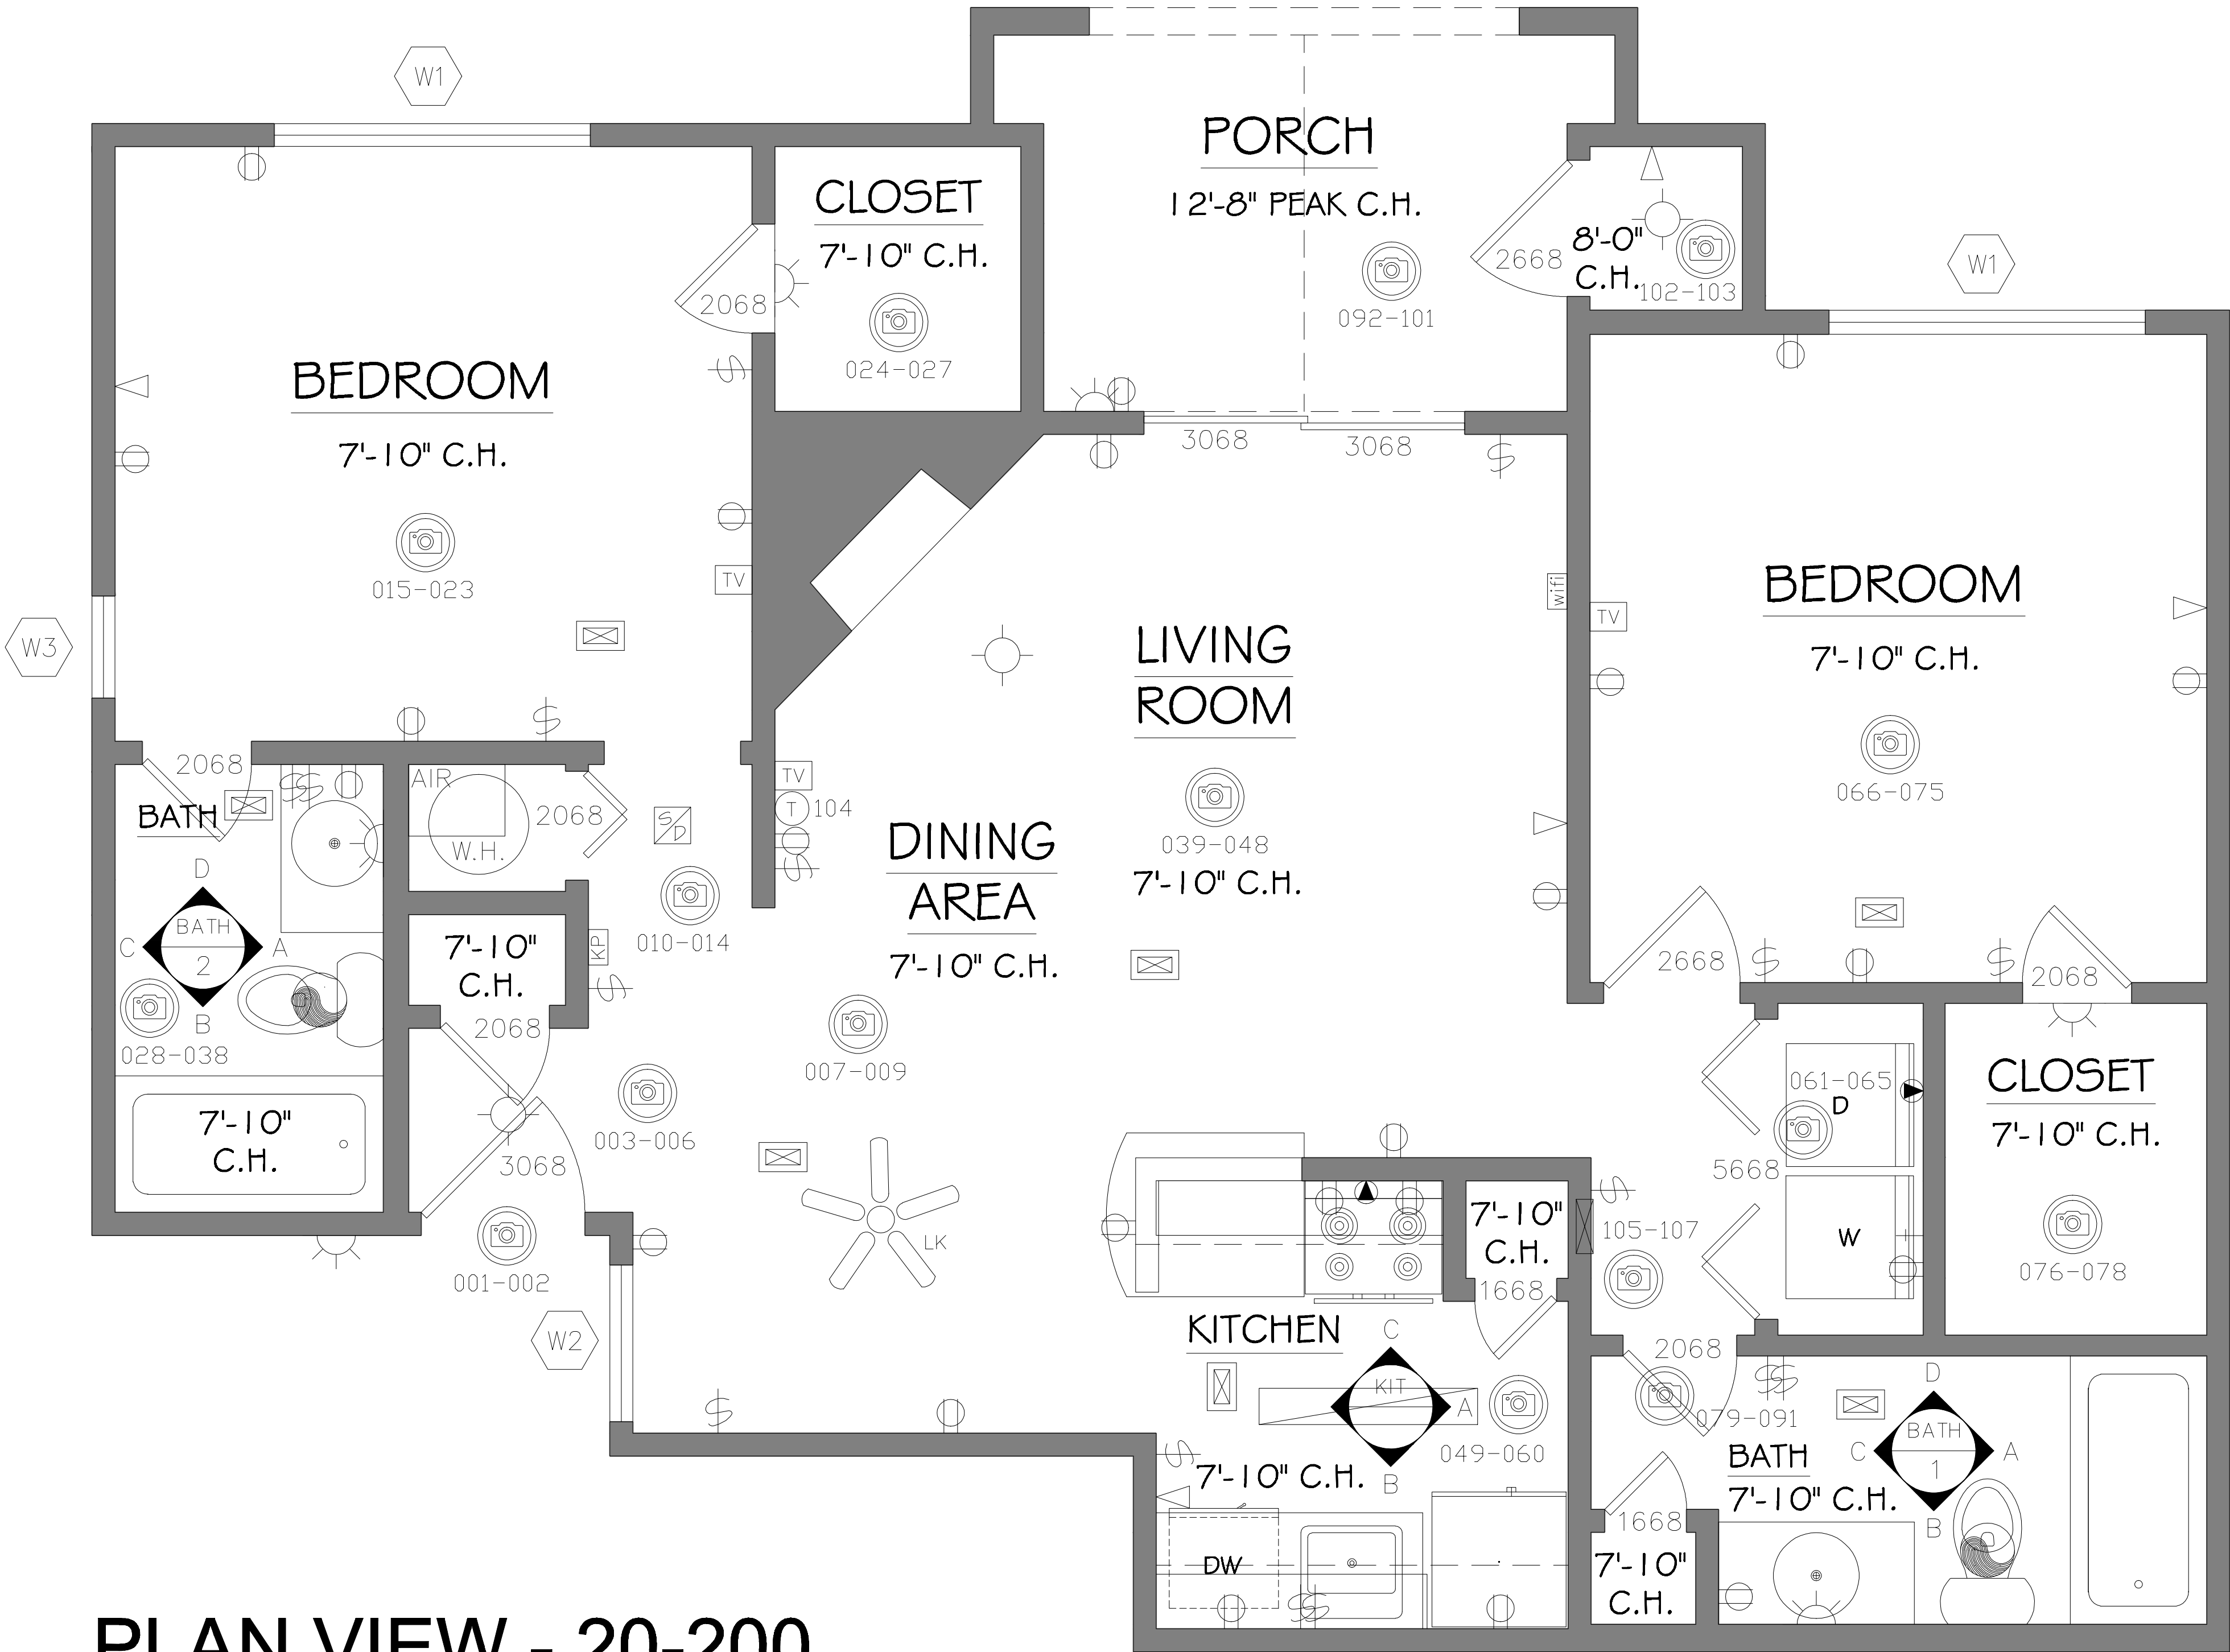

PLAN VIEW - 20-200


ARCHITECTURAL AS BUILT
Meadows Apartments
Louisville, KY 40220

01	ISSUES REVISIONS	DATE
NO.		

UNIT 20-200

HL	PROJECT MANAGER
HL	PROJECT DIRECTOR
012317-1	PROJECT NUMBER
1/2"=1'-0"	SCALE
BB	DRAWN BY
	SHEET NUMBER

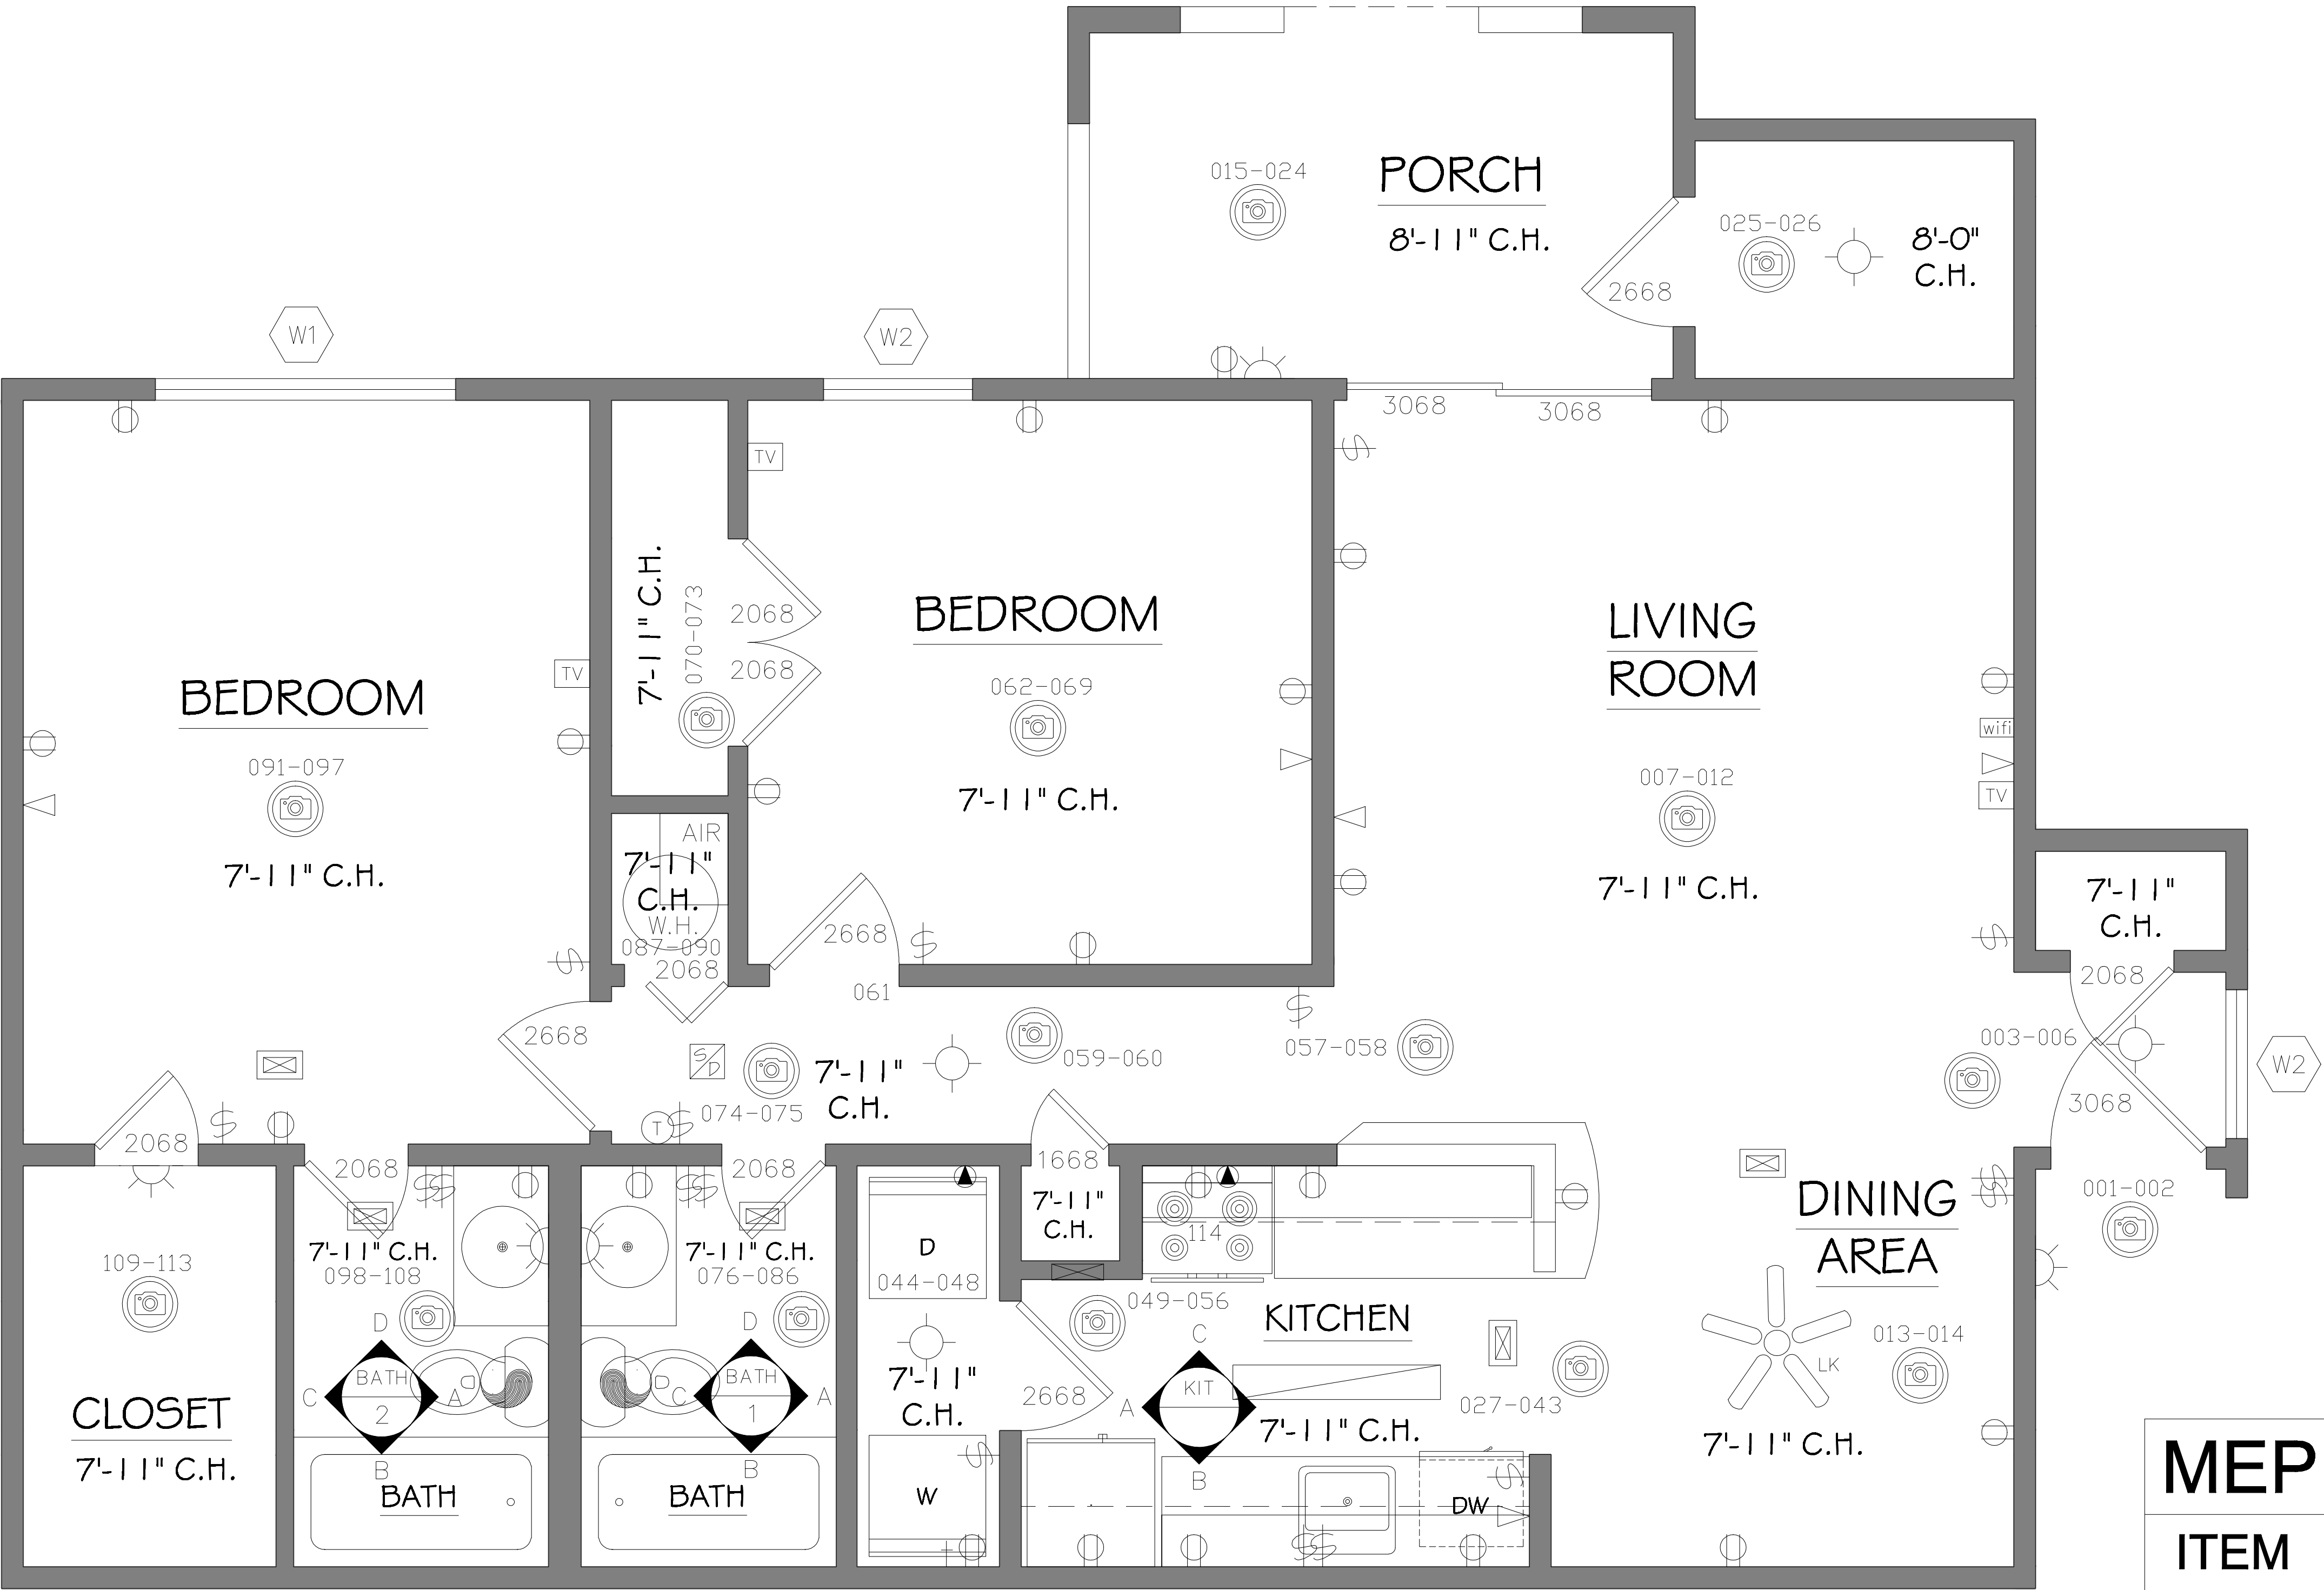AB-4



PLAN VIEW - 24-106

MEP ITEM COUNT	
ITEM	Total Count
Outlets	25
Phone Jacks	5
Data Ports	0
Cable Jacks	3
Switches	17
Dryer Outlet	1
Range Outlet	1

As BUILT

PROFESSIONALS

www.asbuiltprofessionals.com

A DIVISION OF:

AEC

CONSULTANTS INC

844.272.8458

844 AS BUILT

© 2021 AEC CONSULTANTS INC


ARCHITECTURAL AS BUILT

Meadows Apartments


Louisville, KY 40220

01			
NO.	ISSUES REVISIONS	DATE	
		SHEET TITLE	
UNIT 24-106			
HL	PROJECT MANAGER		
HL	PROJECT DIRECTOR		
012317-1	PROJECT NUMBER		
1/2"=1'-0"	SCALE		
BB	DRAWN BY		
	SHEET NUMBER		
AB-6			

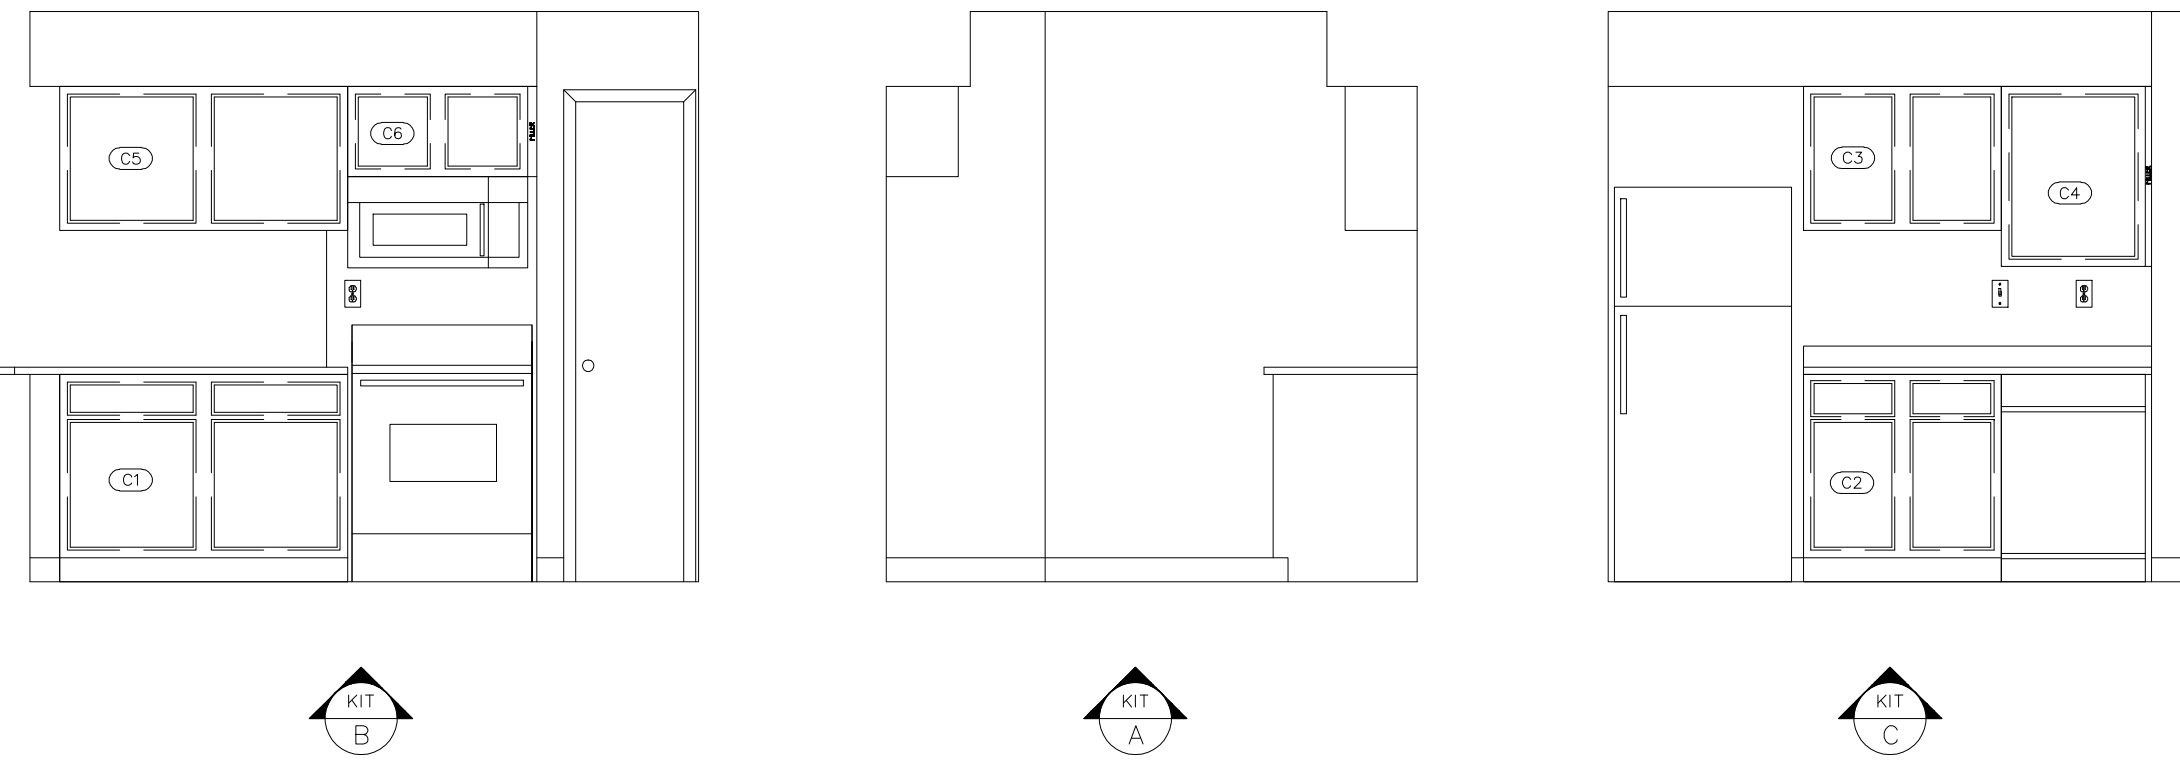
11-102 KITCHEN ELEVATIONS




11-102 BATHROOM ELEVATIONS

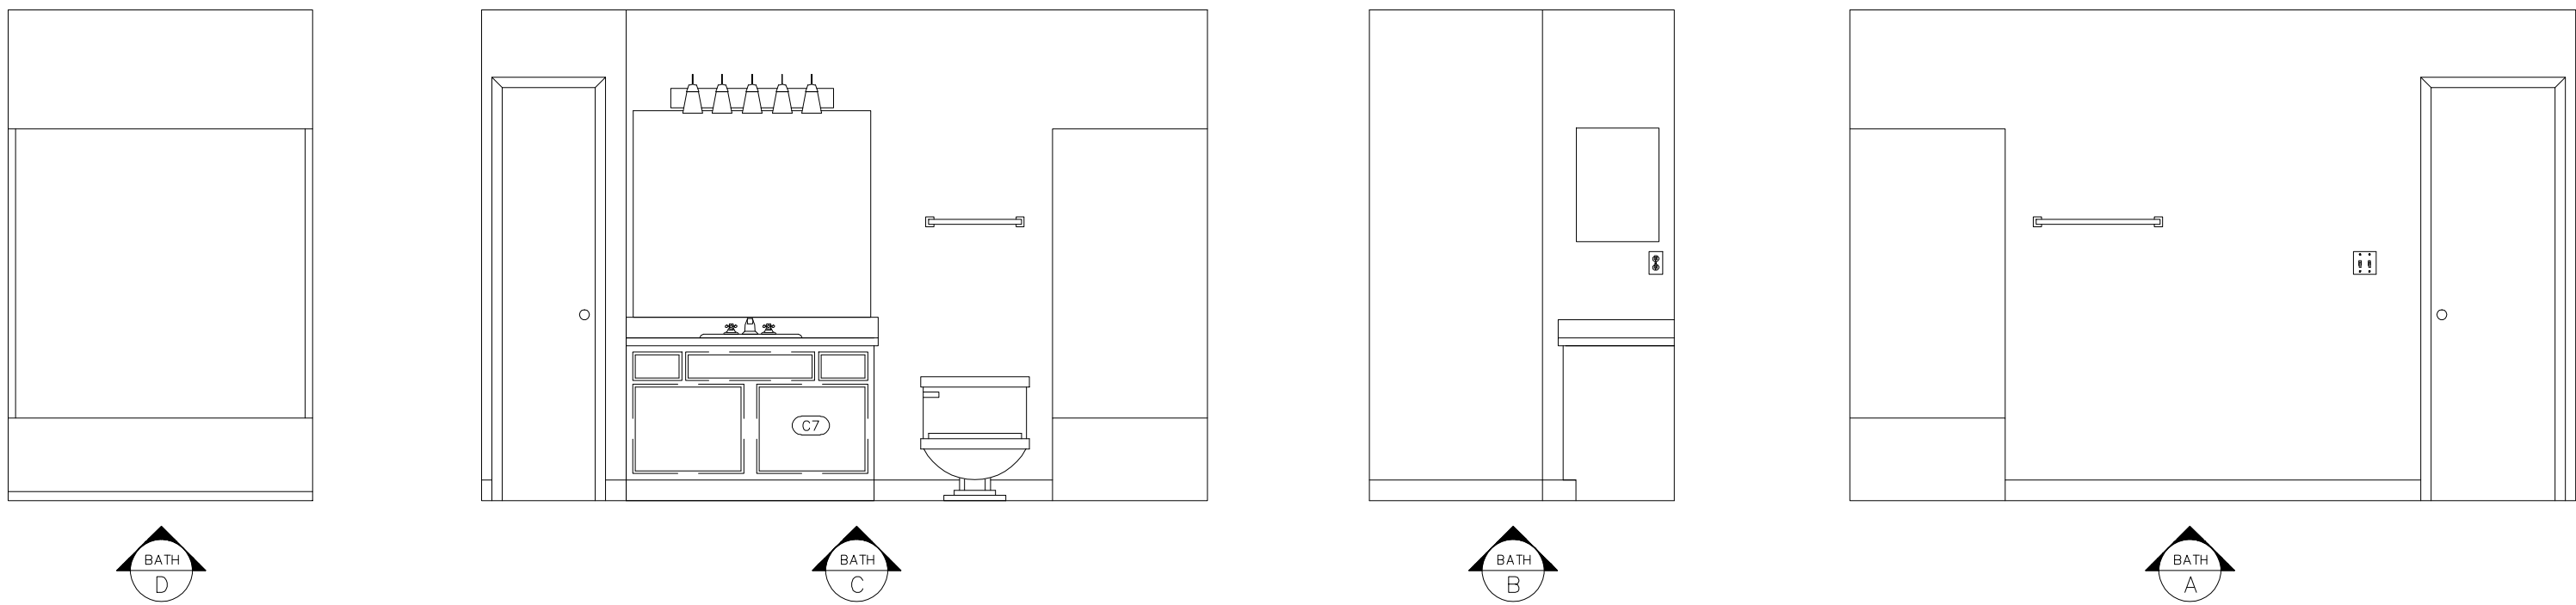


11-200 KITCHEN ELEVATIONS

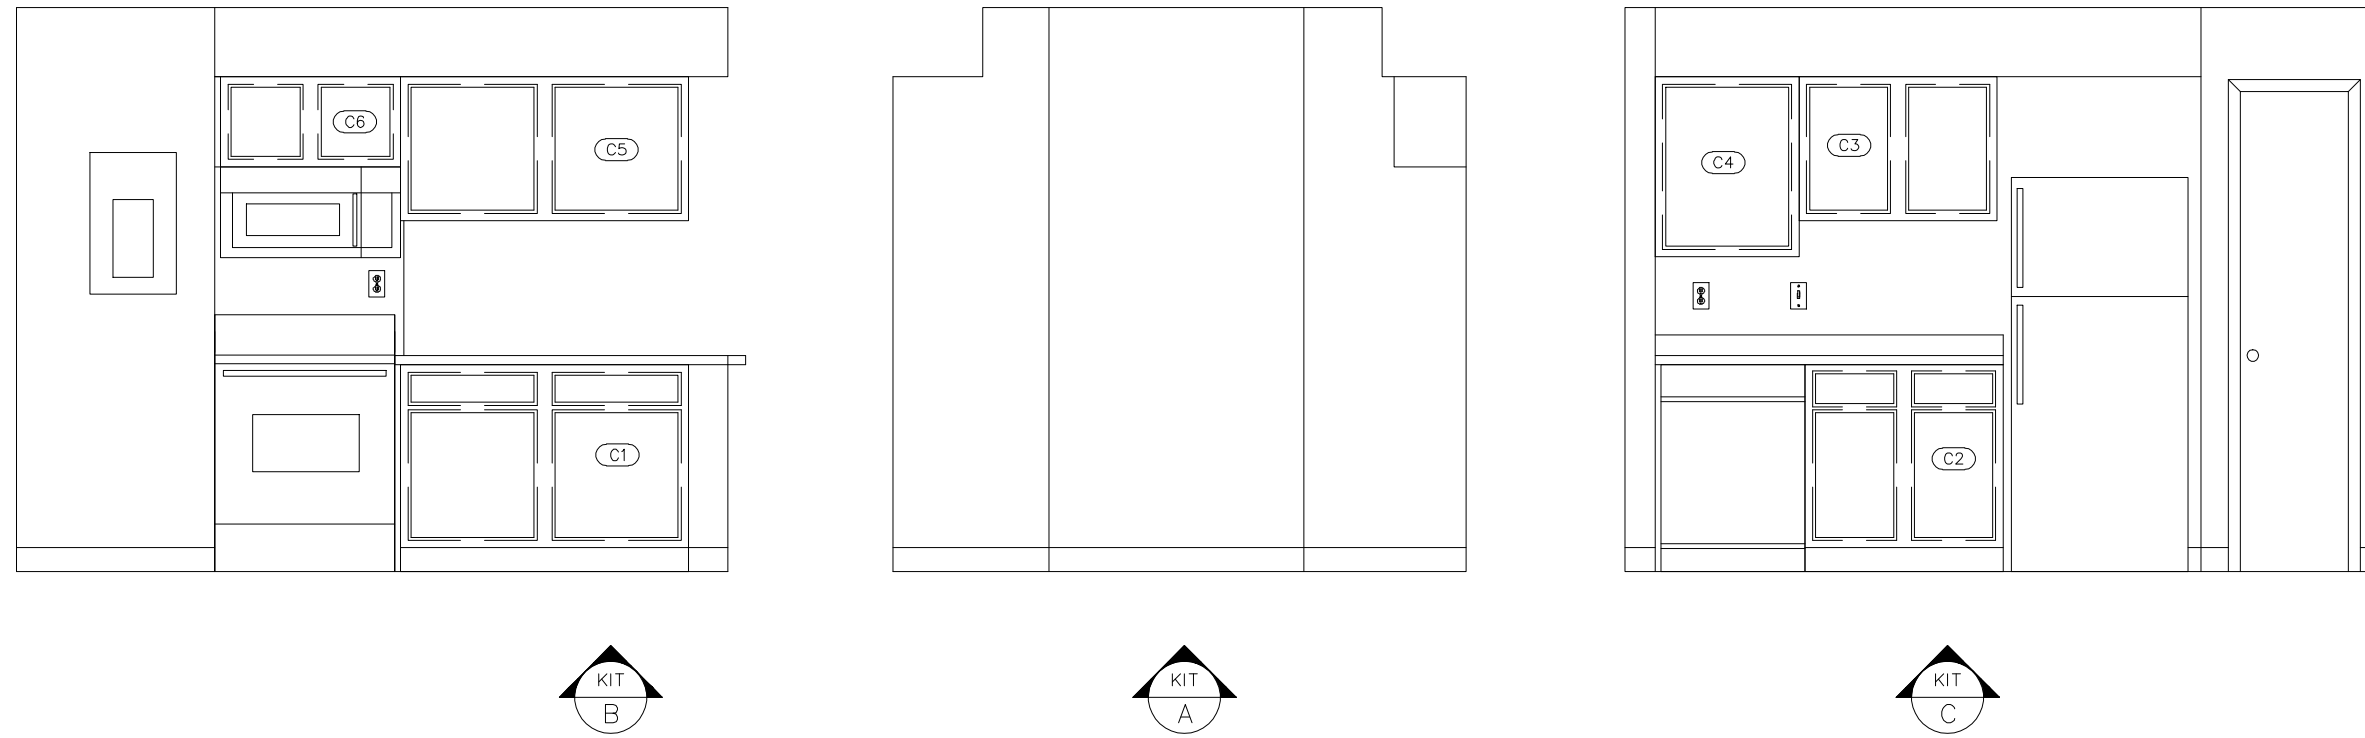


11-200 BATHROOM ELEVATIONS

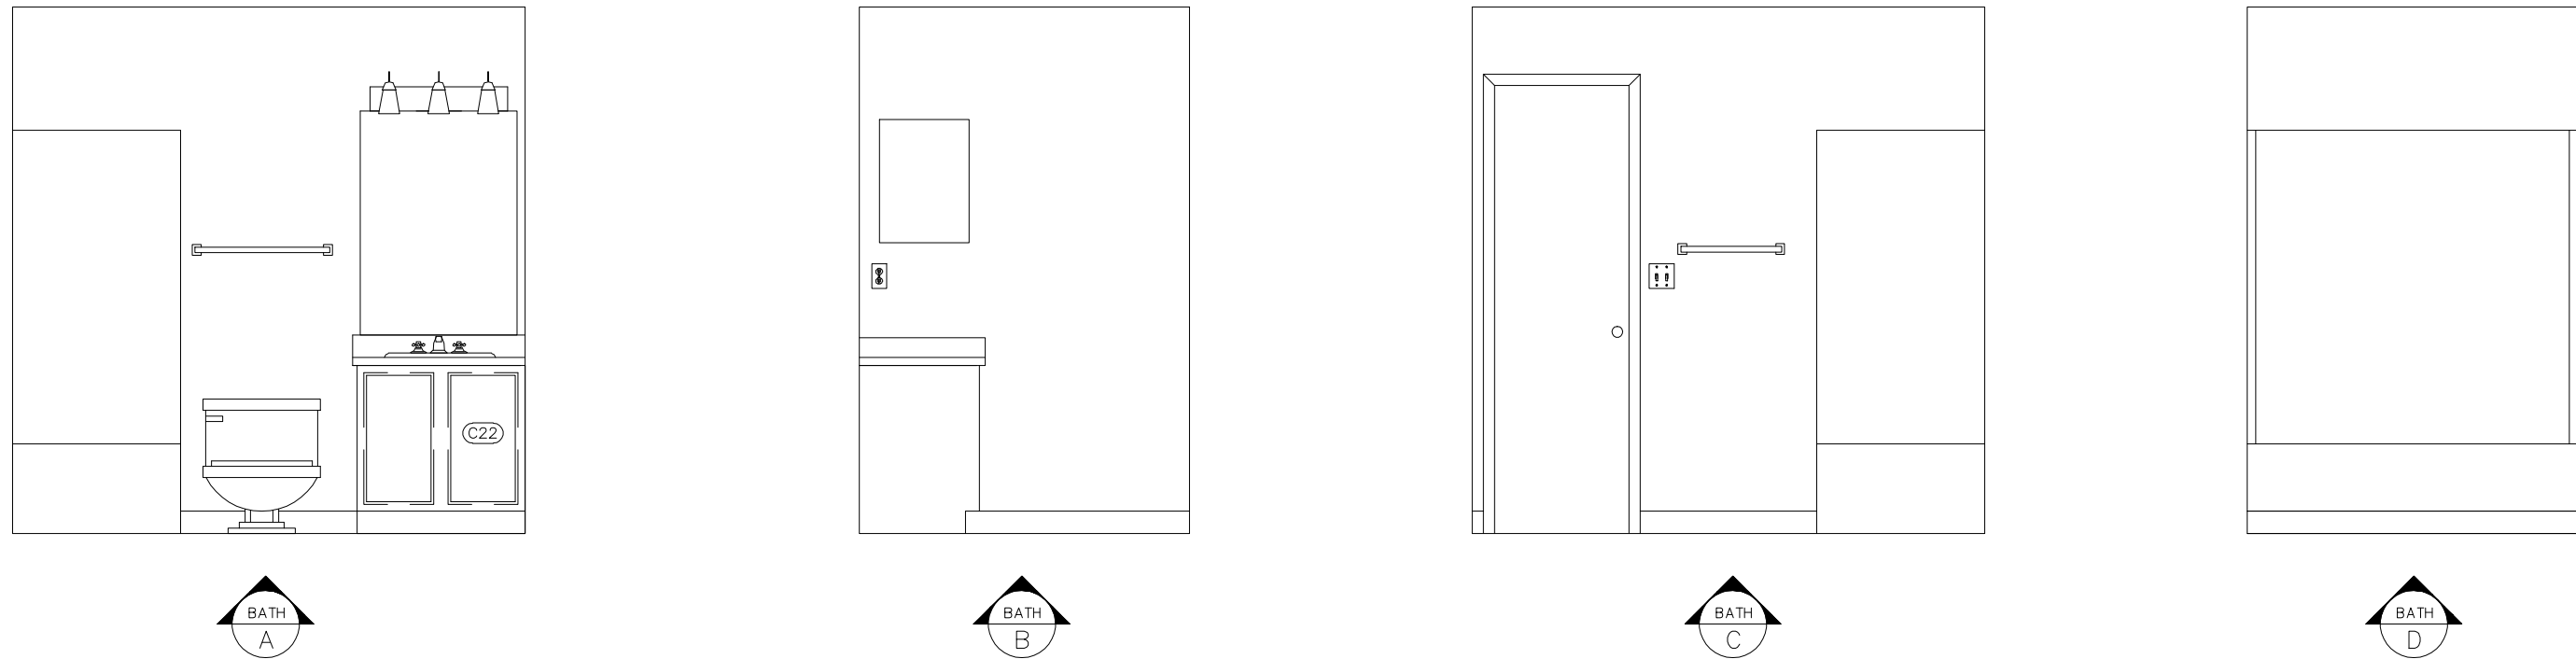

22-103 KITCHEN ELEVATIONS

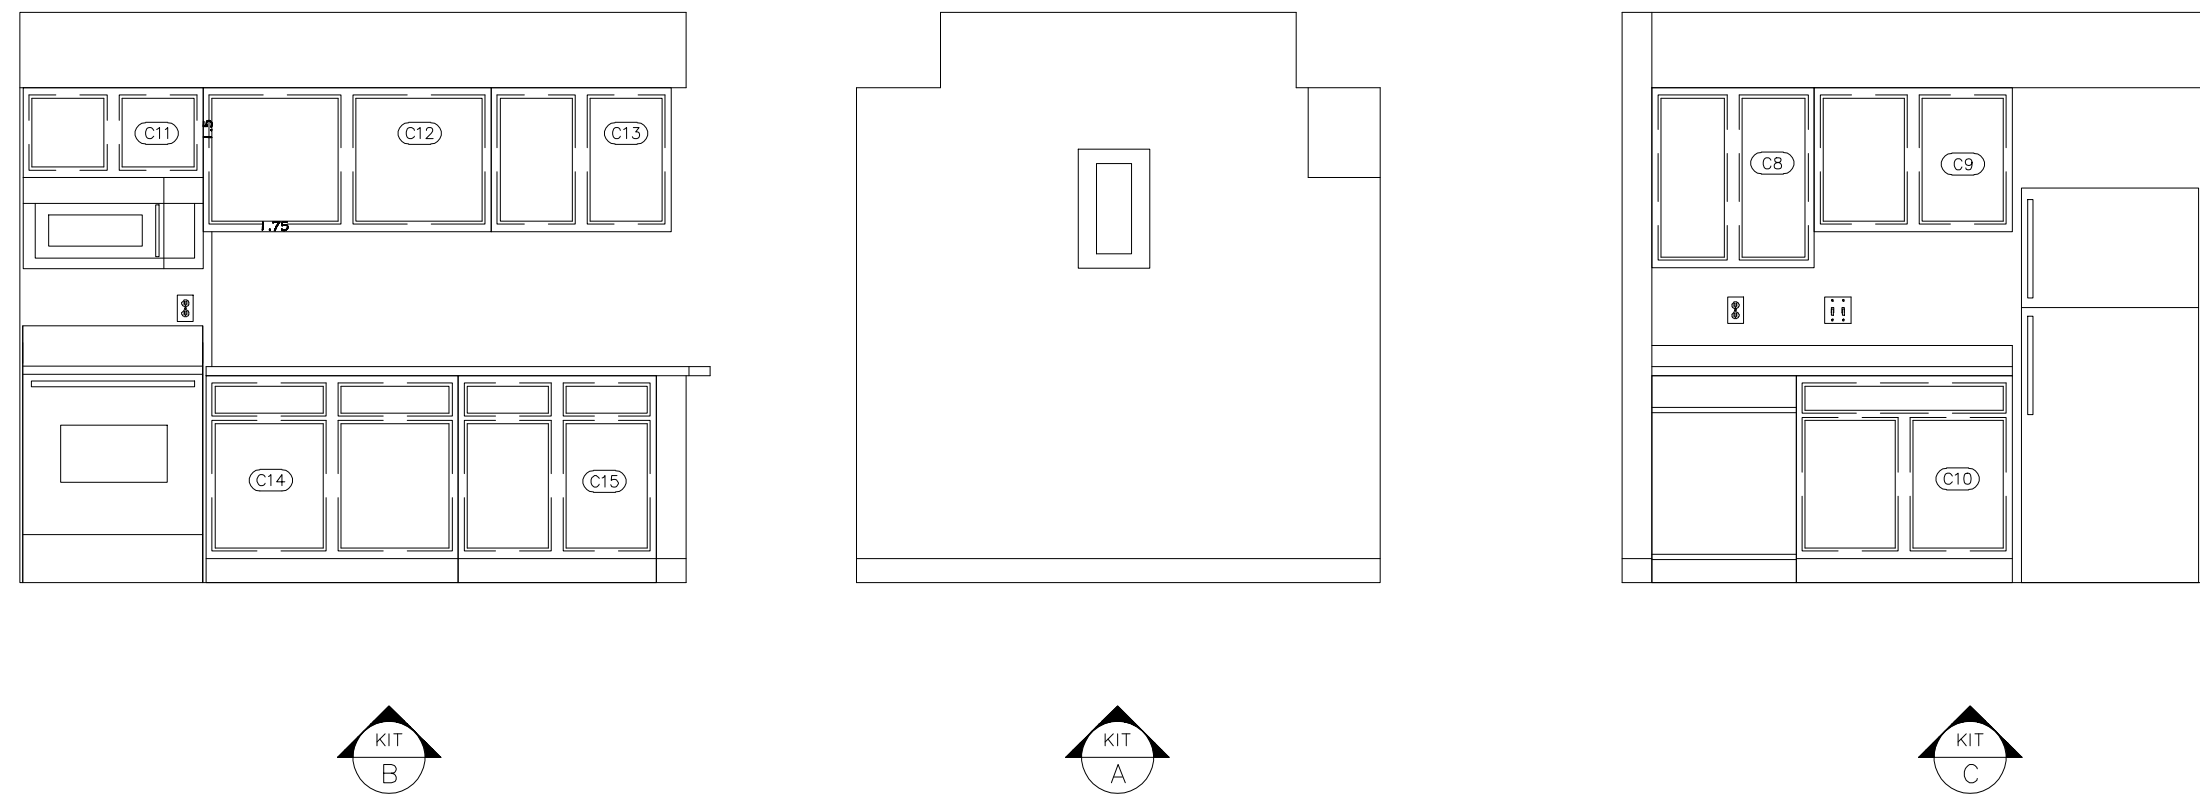

22-103 BATHROOM ELEVATIONS

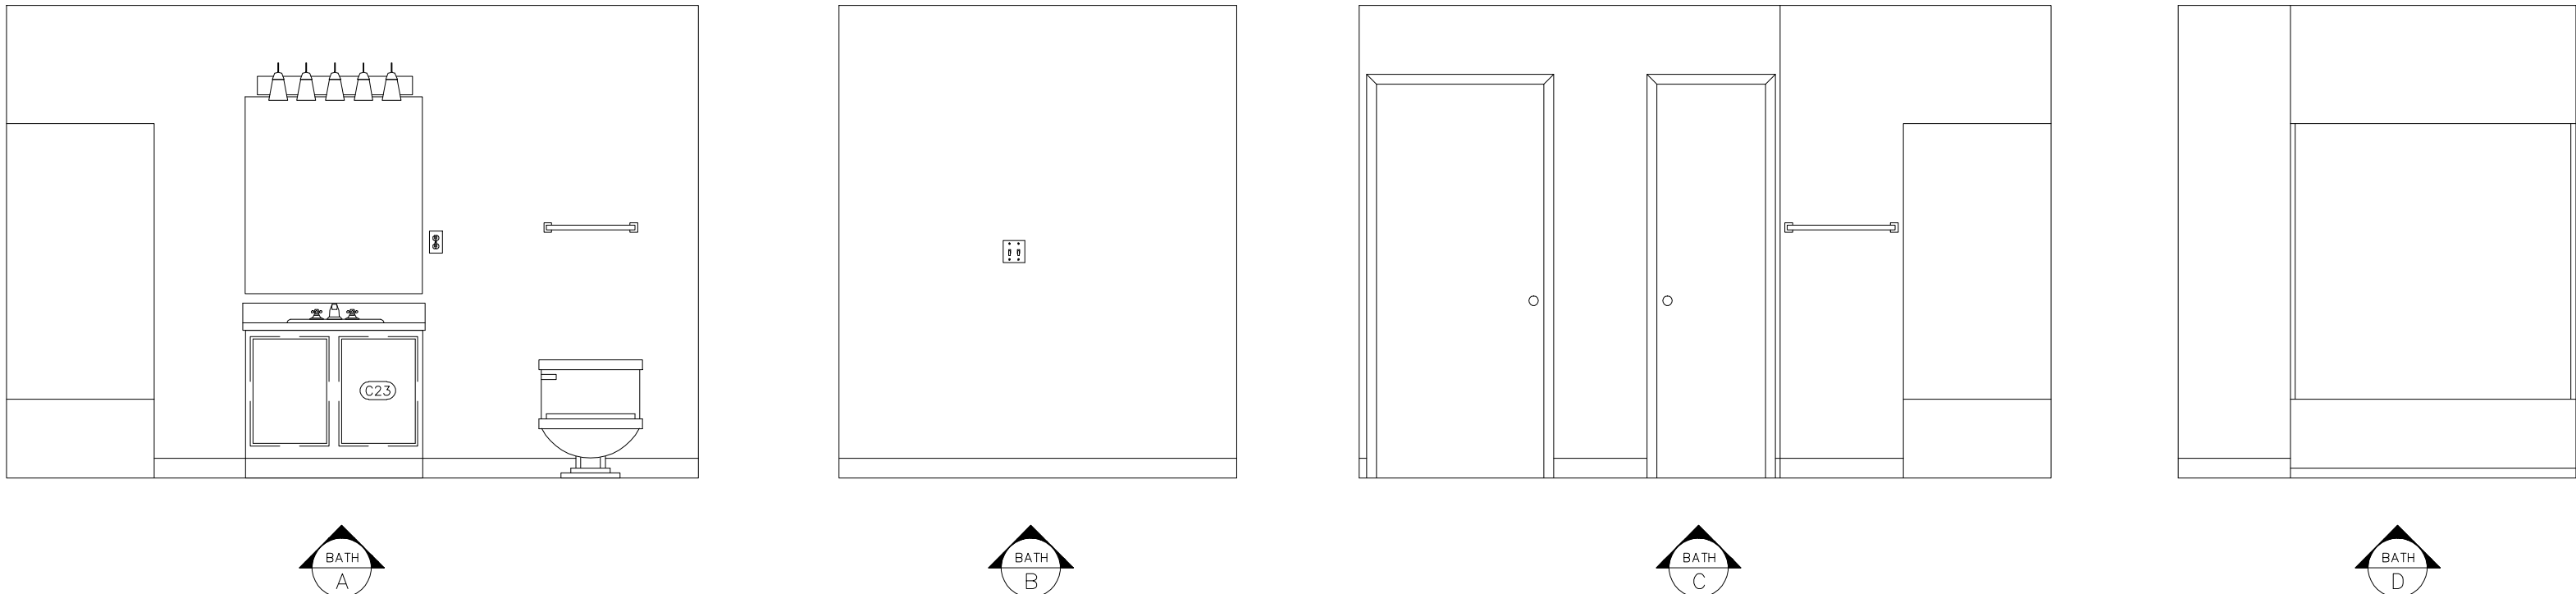

ARCHITECTURAL AS BUILT
Meadows Apartments
Louisville, KY 40220

01		
NO.	ISSUES REVISIONS	DATE

SHEET TITLE

INTERIOR
ELEVATIONS


HL	PROJECT MANAGER
HL	PROJECT DIRECTOR
012317-1	PROJECT NUMBER
3/8"=1'-0"	SCALE
BB	DRAWN BY
	SHEET NUMBER

AB-8


20-200 KITCHEN ELEVATIONS



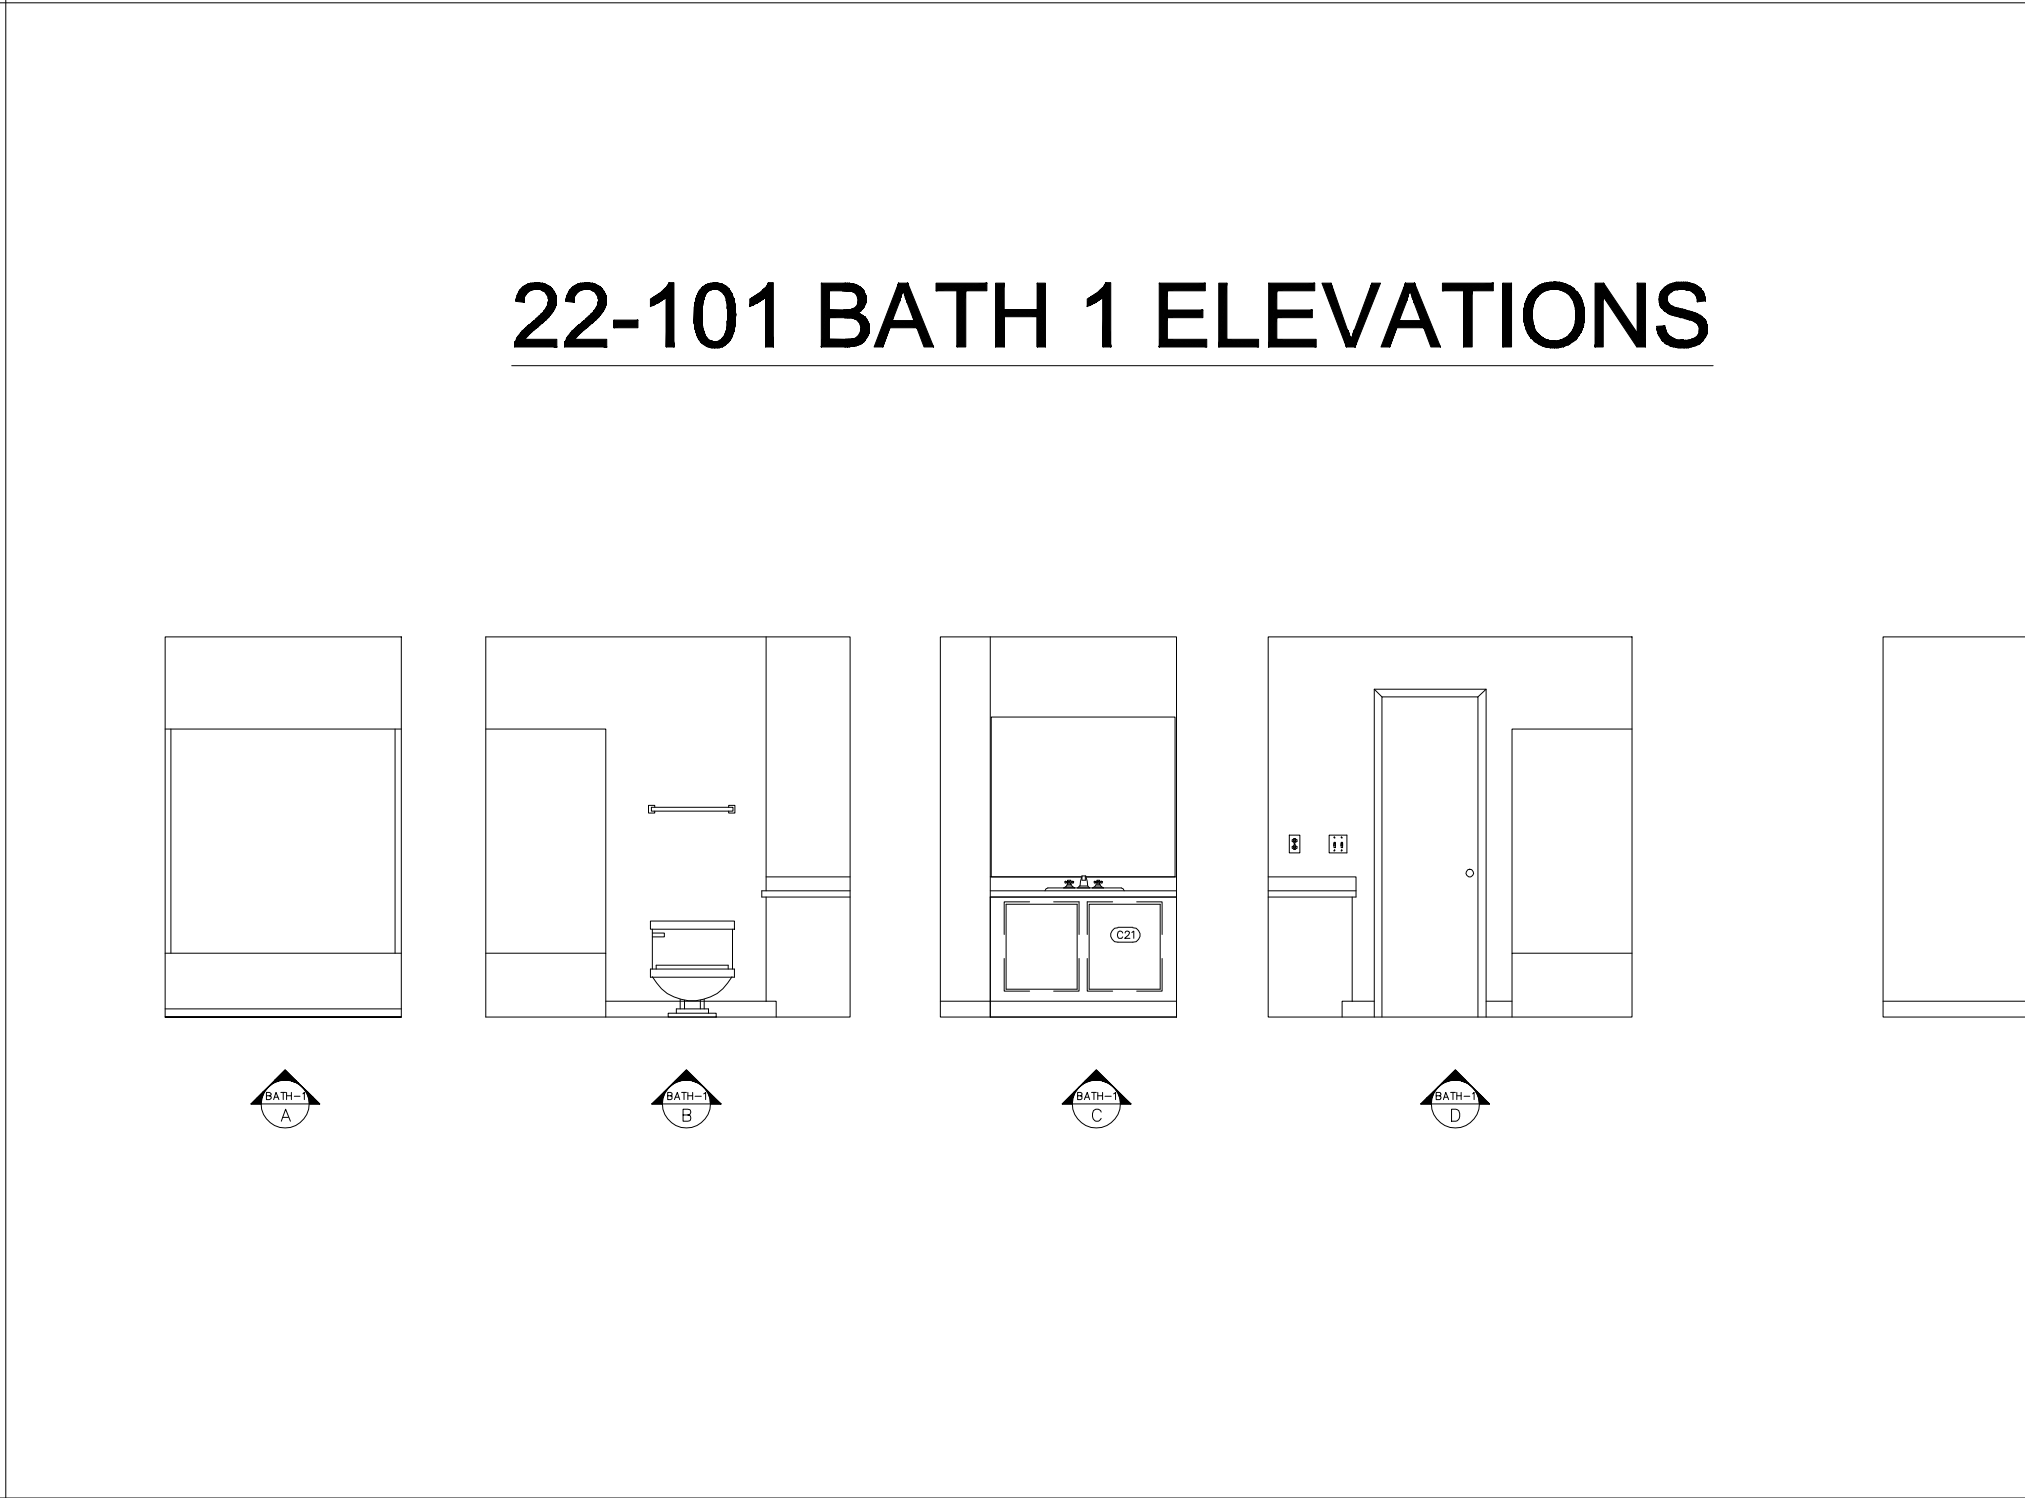20-200 BATH 1 ELEVATIONS




20-200 BATH 2 ELEVATIONS

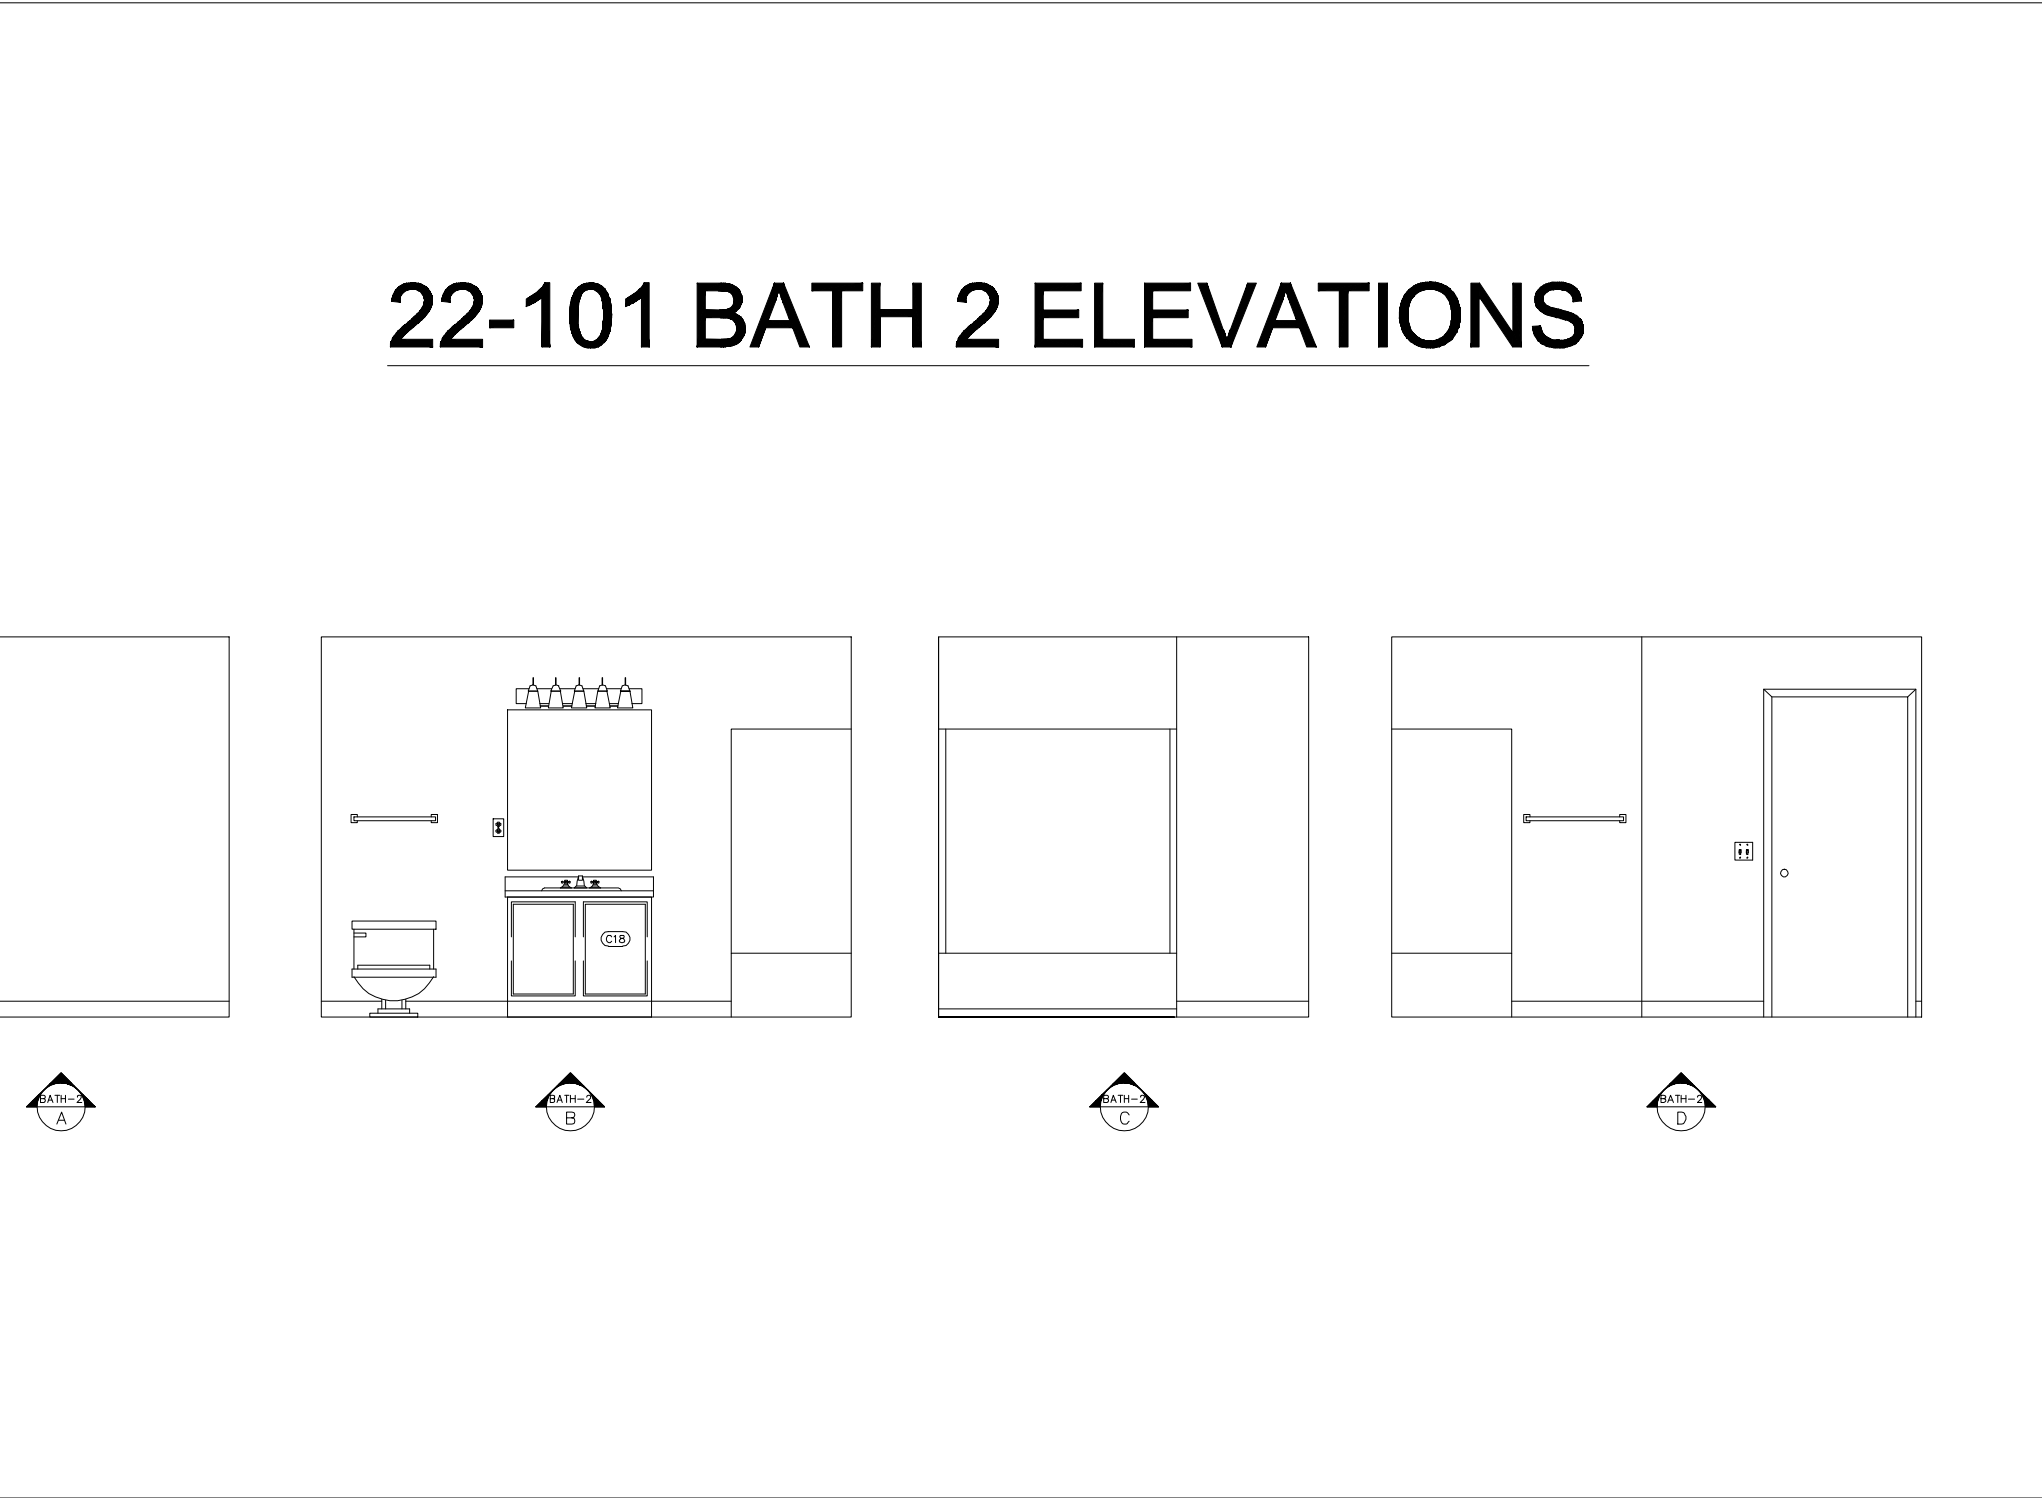

24-106 KITCHEN ELEVATIONS



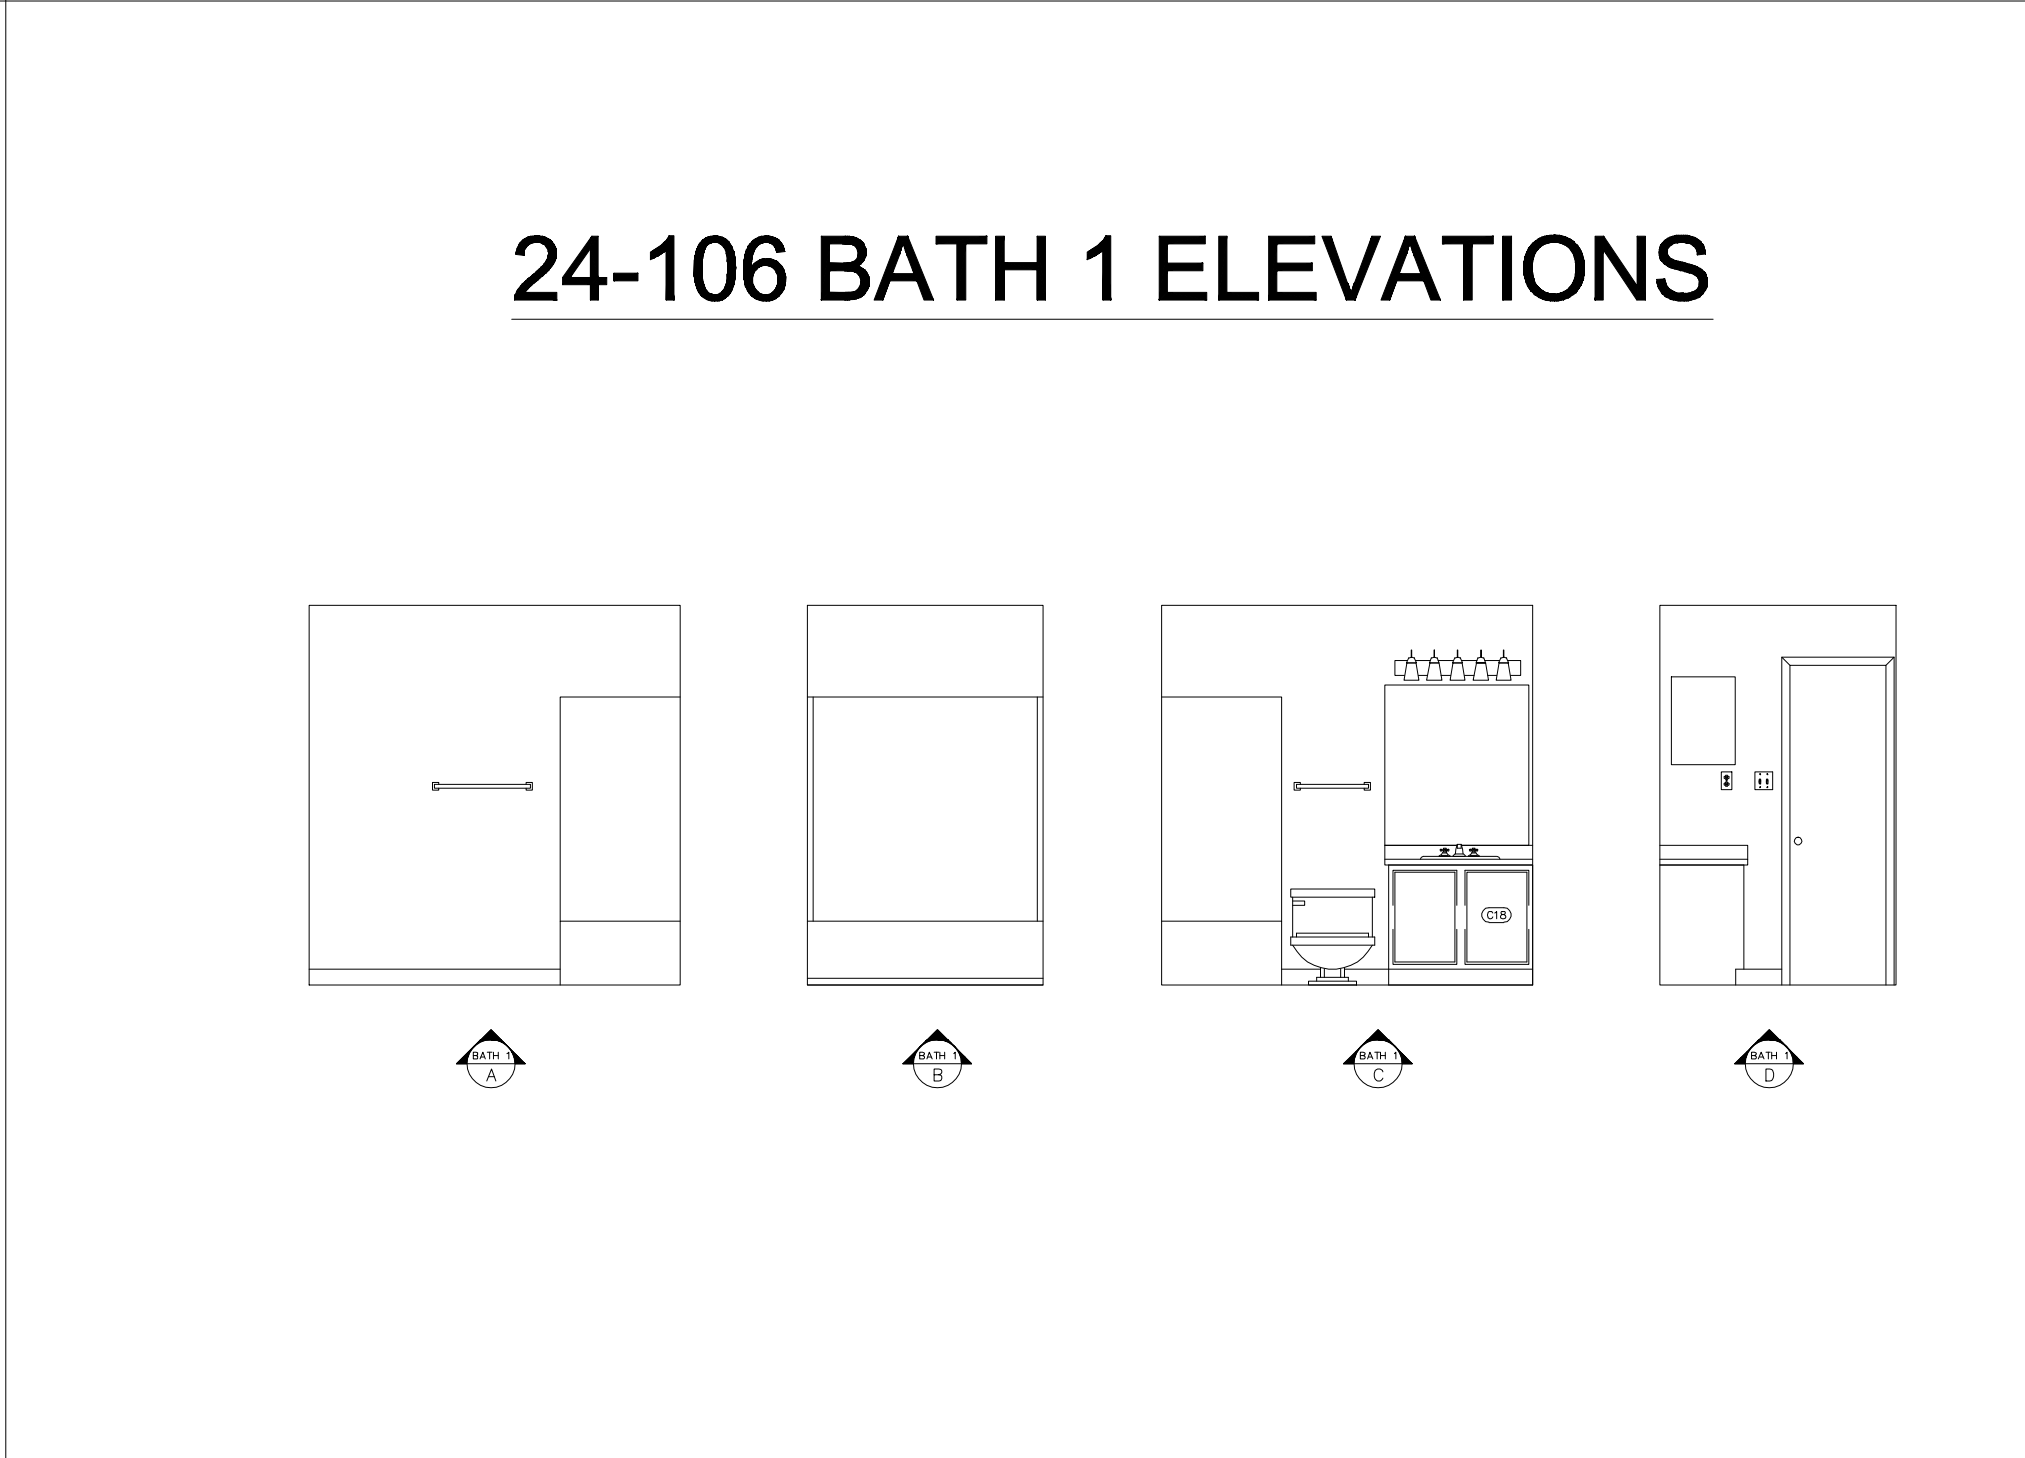24-106 BATH 1 ELEVATIONS



24-106 BATH 2 ELEVATIONS











FEATURES LIST

FEATURE	ATTRIBUTE	11-102	11-200	22-103	20-200	24-106	22-101
Ceiling Fan	Diameter	42"	NONE	42"	42"	42"	42"
Ceiling Light	Size	4'-0" X 8"	4'-0" X 8"	4'-0" X 8"	4'-0" X 8"	4'-0" X 8"	4'-0" X 8"
Dishwasher	Width	24"	24"	24"	24"	24"	24"
Dryer Receptacle	Type	NONE	NONE	NONE	3 PRONG	3 PRONG	NONE
Garbage Disposal	Yes / No	YES	YES	YES	YES	YES	YES
Ice Maker	Yes / No	YES	YES	YES	YES	YES	YES
Medicine Cabinet	Width / Height	16"W X 22"H	16"W X 22"H	NONE	16"W X 22"H	16"W X 22"H	NONE
Range Receptacle	Type	3 PRONG	3 PRONG	3 PRONG	3 PRONG	3 PRONG	3 PRONG
Vents/Registers	Width / Length	5.5"W X 9.5"H	5.5"W X 9.5"H	5.5"W X 11.5"H	16"W X 7.5"H	16"W X 7.5"H	16"W X 7.5"H
		13.5"W X 9.5"H	15.5"W X 11.5"H	13.5"W X 7.5"H	5.5"W X 11.5"H	5.5"W X 11.5"H	5.5"W X 11.5"H
		11.5"W X 7.5"H	11.5"W X 7.5"H	11.5"W X 7.5"H	13.5"W X 9.5"H	13.5"W X 9.5"H	13.5"W X 9.5"H
					11.5"W X 7.5"H	11.5"W X 7.5"H	11.5"W X 7.5"H
Thermostat	PHOTO						
Toilet Bowl	Round or Elongated	ELONGATED	ELONGATED	ELONGATED	ELONGATED	ELONGATED	ELONGATED
Towel Bar	Length	24"/18"	24"/18"	22"/18"	24"	24"/18"	18"
Vanity Mirror	Width / Height	46"W X 40"H	28"W X 40"H	36"W X 40"H	42"W X 40"H	36"W X 40"H	36"W/46"W X 40"H
Vanity Sink	Oval or Round/Dim	ROUND - 19"DIA	ROUND - 19"DIA	ROUND - 19"DIA	ROUND - 19"DIA	ROUND - 19"DIA	ROUND - 19"DIA
Viewer/Knocker	PHOTO						
















Window Schedule

Window	Width	Height	Sill Ht.	Header Ht.
W1	5'-9.5"	5'-10"	1'-0"	6'-10"
W2	2'-10.5"	5'-10"	1'-0"	6'-10"
W3	1'-10.5"	5'-10"	1'-0"	6'-10"
W4	5'-10.5"	5'-10"	1'-0"	6'-10"

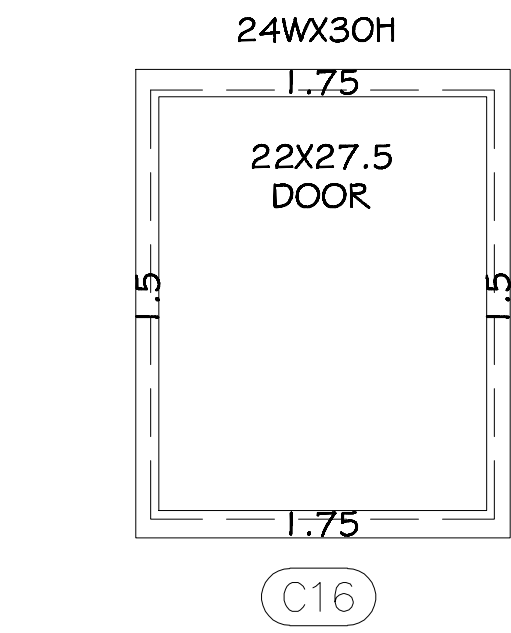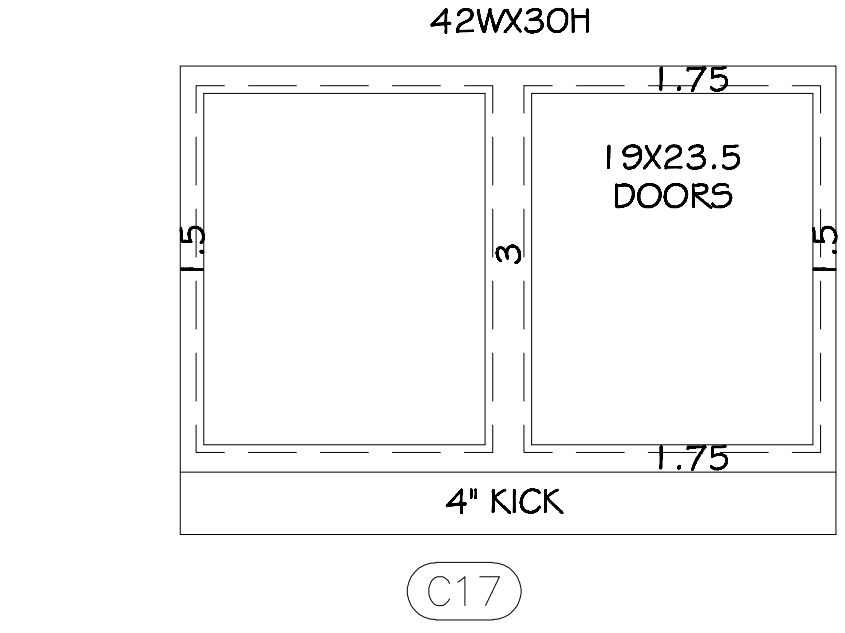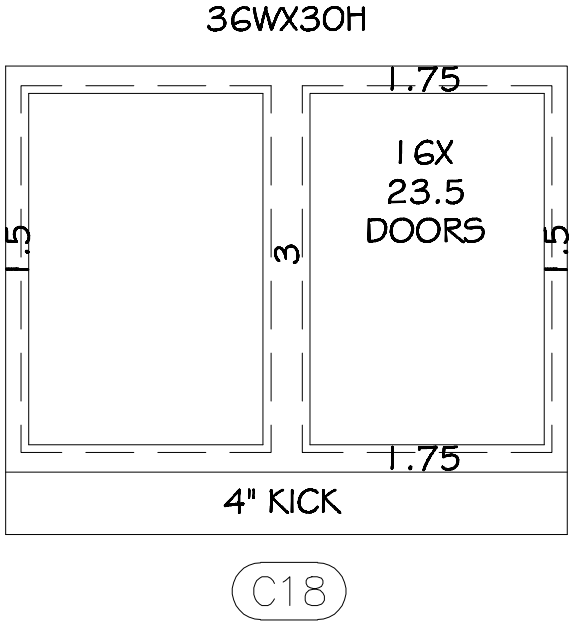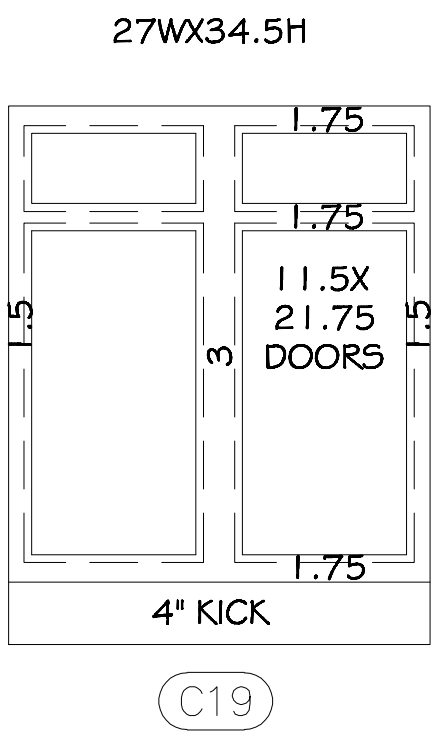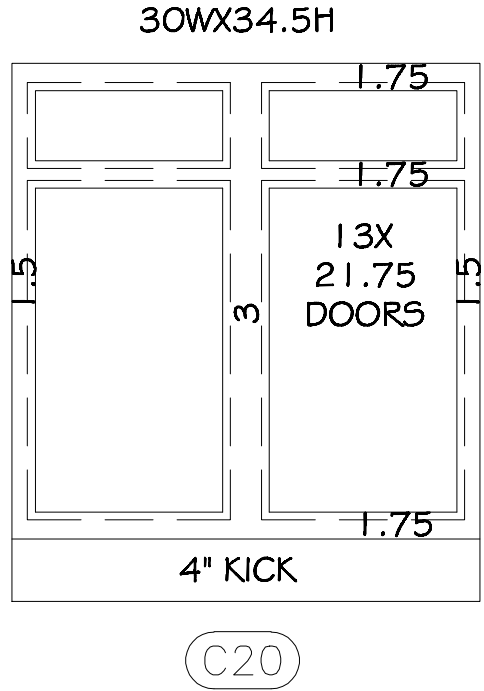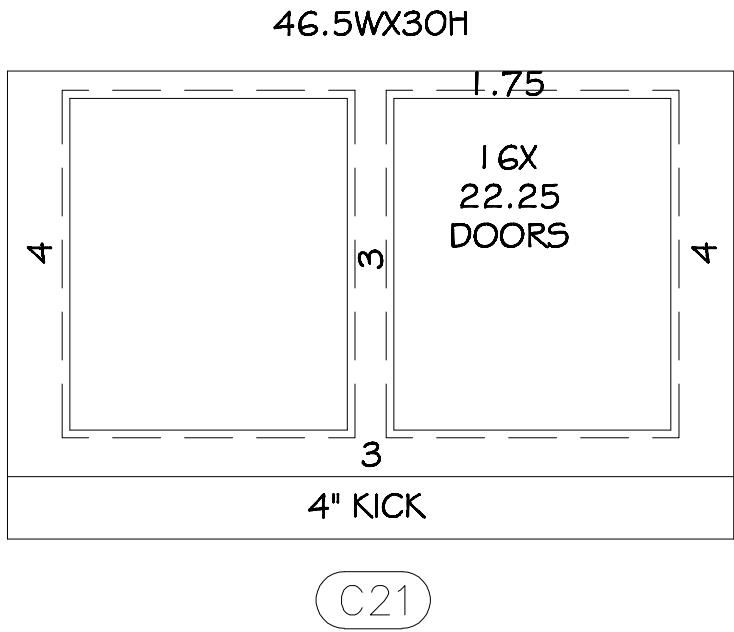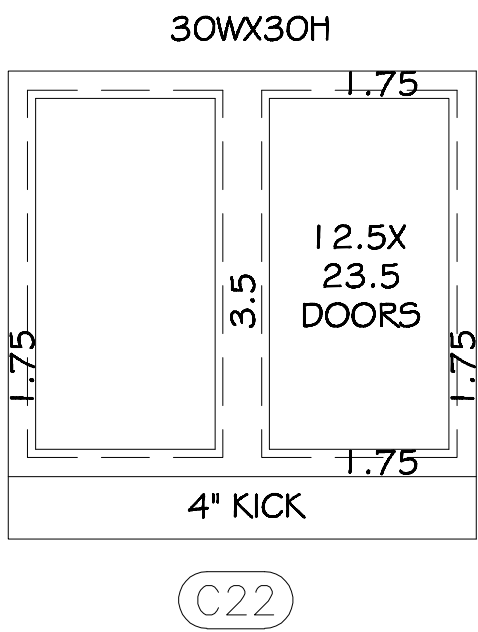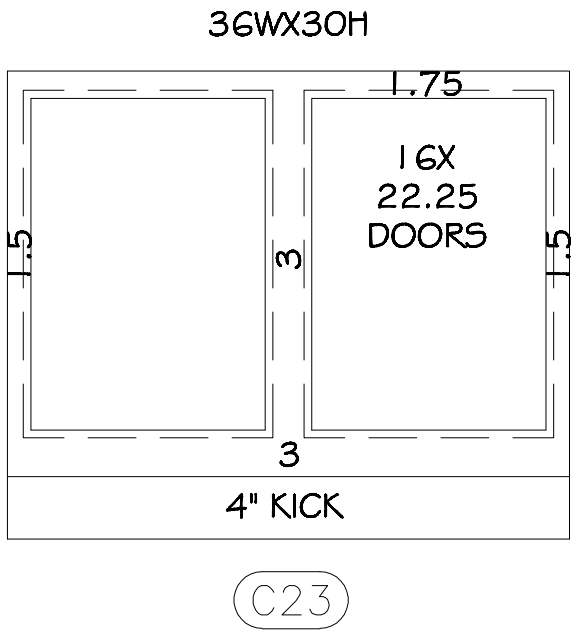(DOOR SCHEDULE SIZES LISTED ON FLOOR PLANS)

VISUAL CABINET SCHEDULE

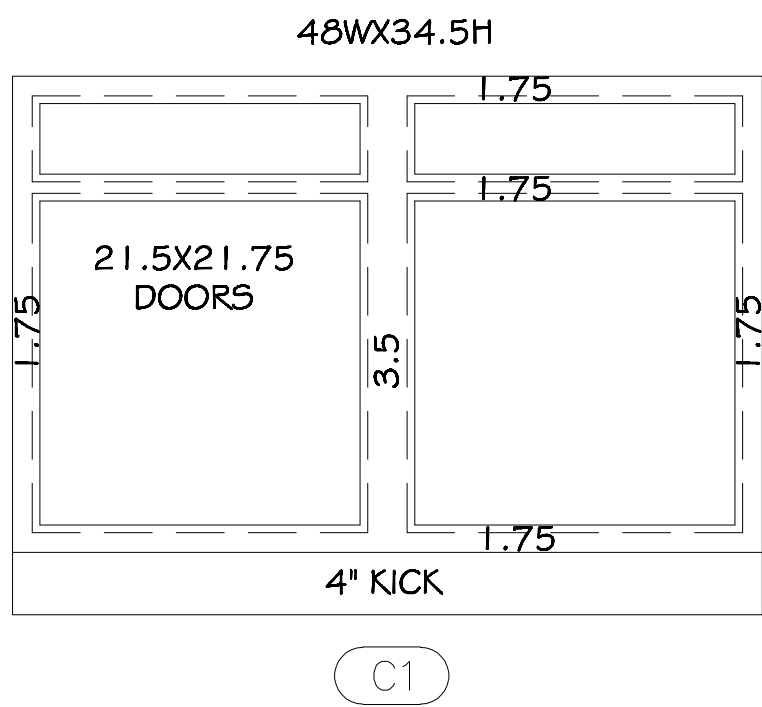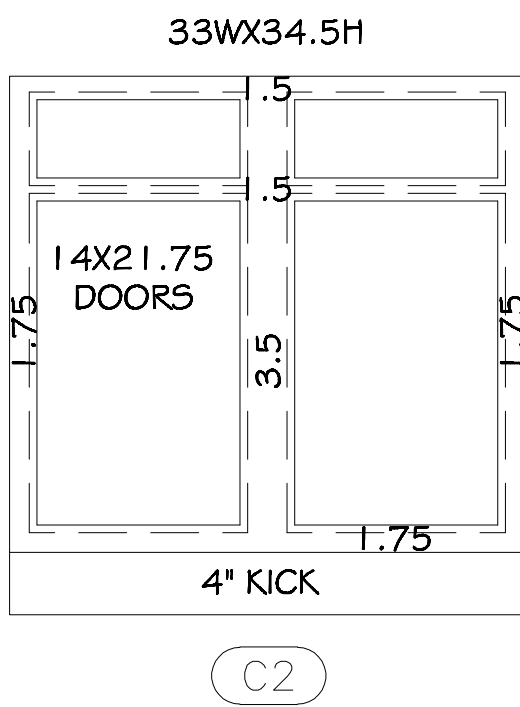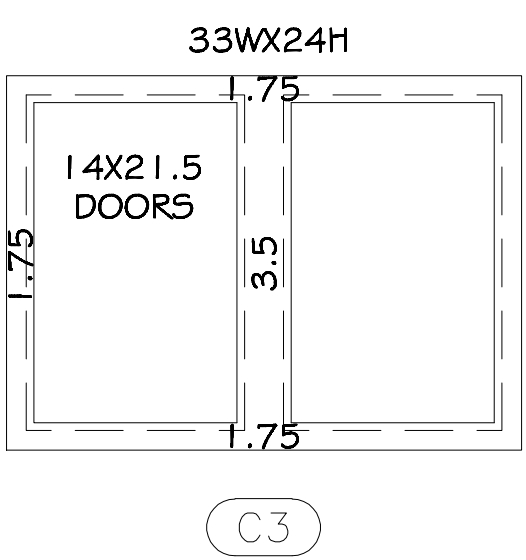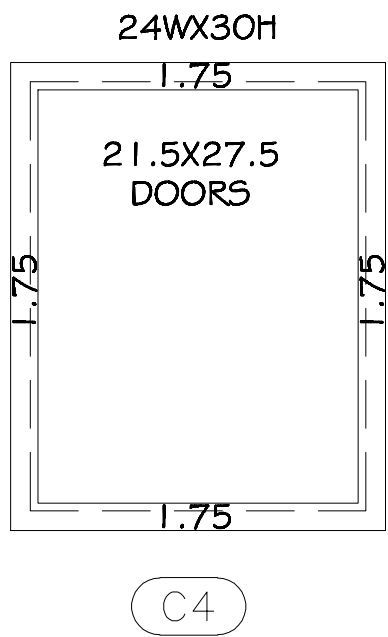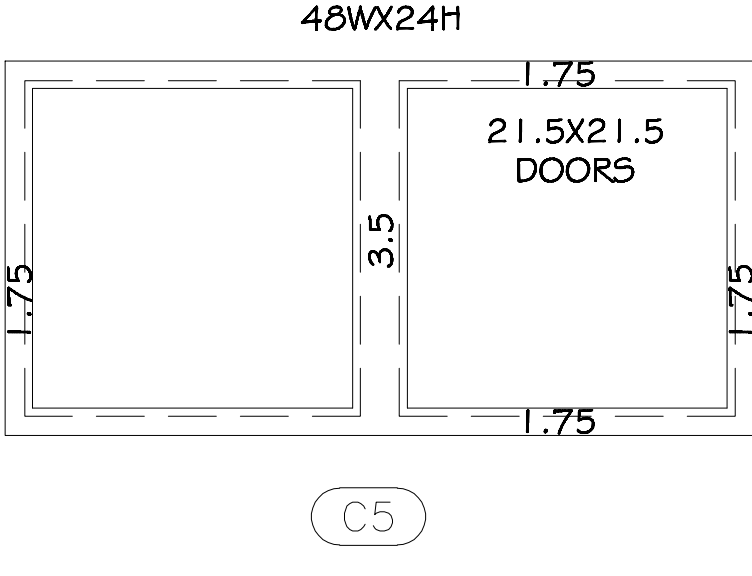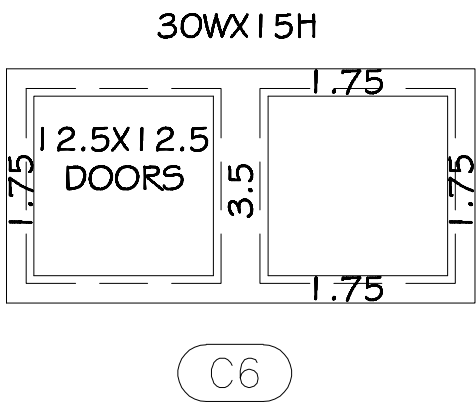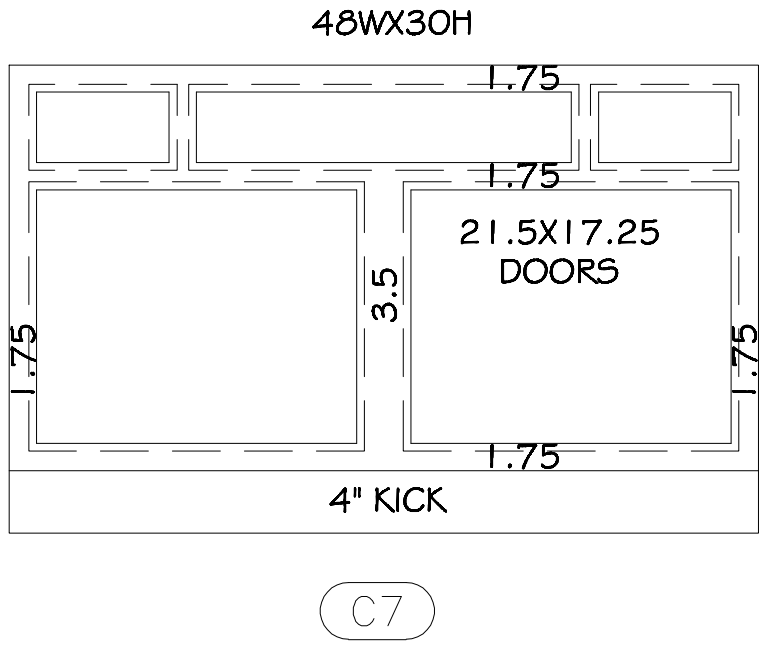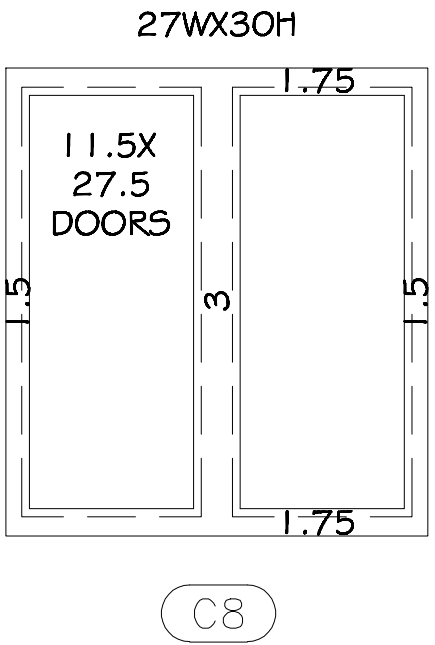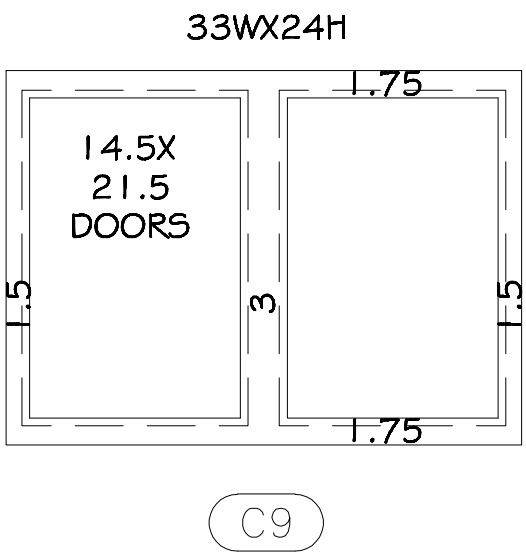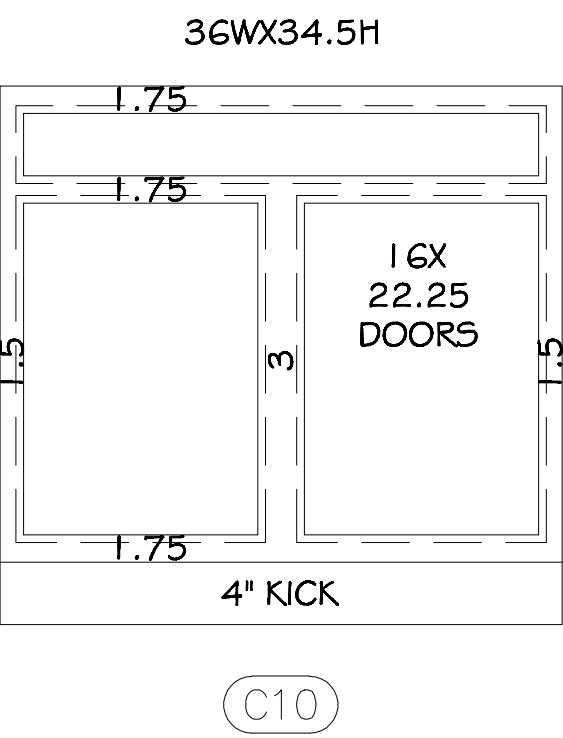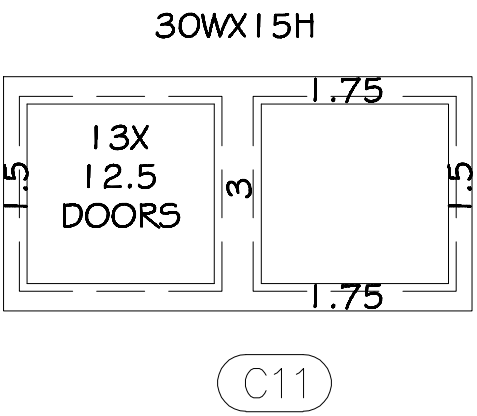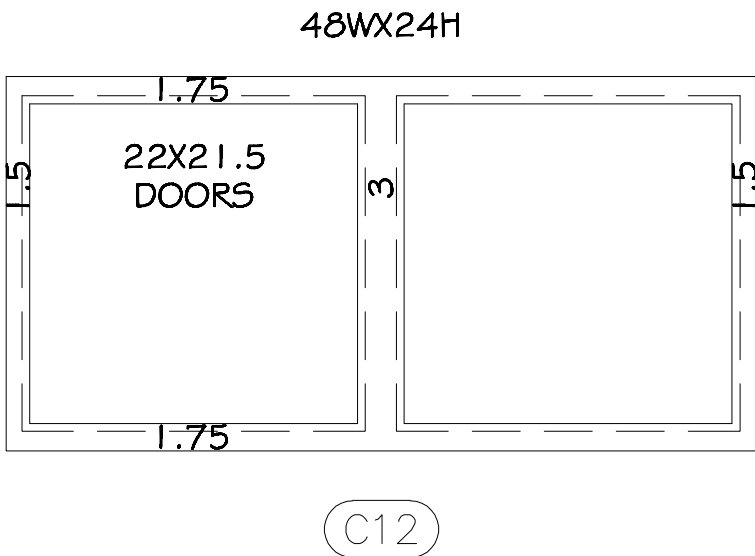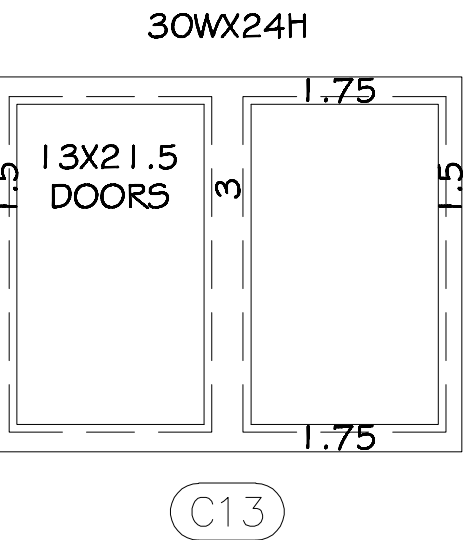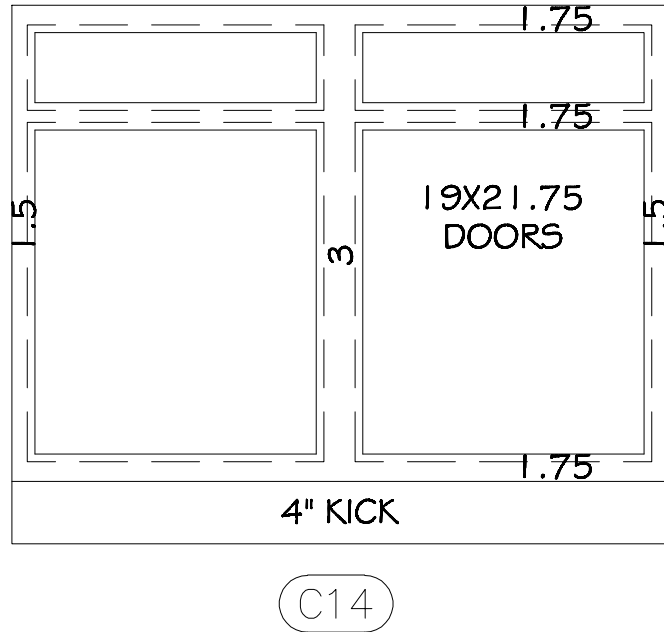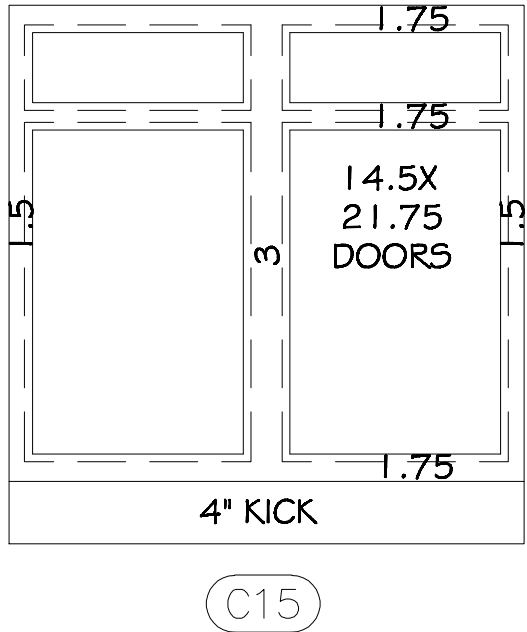As BUILT

PROFESSIONALS

www.asbuiltprofessionals.com

A DIVISION OF:

AEC

CONSULTANTS INC

844.272.8458
844 A S BUILT

© 2021 AEC CONSULTANTS INC

ARCHITECTURAL AS BUILT

Meadows Apartments

Louisville, KY 40220

01

NO. ISSUES | REVISIONS

DATE

SHEET TITLE

FEATURES LIST AND SCHEDULES

HL PROJECT MANAGER

HL PROJECT DIRECTOR

012317-1 PROJECT NUMBER

NTS SCALE

BB DRAWN BY

SHEET NUMBER

AB-10