


SUNNYVALE, CA 94087



100% SUBMITTAL


C-1	COVER SHEET DRAWING INDEX	AB-24	131 FLOOR PLAN & RCP
SL	SYMBOLS LEGEND	AB-25	129 FLOOR PLAN & RCP
SP-1	SITE PLAN OF BUILDINGS 2, 3, AND 4	AB-26	127 FLOOR PLAN & RCP
AB-1	BUILDING 1 FLOORPLAN	AB-27	123 FLOOR PLAN & RCP
AB-2	BUILDING 1 ENLARGED FLOORPLAN	AB-28	121 FLOOR PLAN & RCP
AB-3	BUILDING 1 ROOF PLAN	AB-29	117 FLOOR PLAN & RCP
AB-4	BUILDING 1 ELEVATIONS	AB-30	115 FLOOR PLAN & RCP
AB-5	BUILDING 2 FLOORPLAN	AB-31	111 FLOOR PLAN & RCP
AB-6	BUILDING 2 FLOORPLAN	AB-32	219 FLOOR PLAN & RCP
AB-7	BUILDING 2 FLOORPLAN 2ND FLOOR	AB-33	217 FLOOR PLAN & RCP
AB-8	BUILDING 2 ROOF PLAN	AB-34	215 FLOOR PLAN & RCP
AB-9	BUILDING 2 ROOF PLAN	AB-35	213 FLOOR PLAN & RCP
AB-10	BUILDING 2 EXTERIOR ELEVATIONS	AB-36	211 FLOOR PLAN & RCP
AB-11	BUILDING 2 EXTERIOR ELEVATIONS	AB-37	PUBLIC RESTROOMS FLOORPLAN & RCP
AB-12	BUILDING 3 FLOOR PLAN	AB-38	109 FLOOR PLAN & RCP
AB-13	BUILDING 3 ROOF PLAN	AB-39	107 FLOOR PLAN & RCP
AB-14	BUILDING 3 ELEVATIONS	AB-40	1107 FLOOR PLAN & RCP
AB-15	BUILDING 4 FLOOR PLAN	AB-41	1105 FLOOR PLAN & RCP
AB-16	BUILDING 4 ROOF PLAN	AB-42	1101 FLOOR PLAN & RCP
AB-17	BUILDING 4 ELEVATIONS		
AB-18	1167-109 FLOOR PLAN & RCP		
AB-19	1167-101 FLOOR PLAN & RCP		
AB-20	137 FLOOR PLAN & RCP		
AB-21	135 FLOOR PLAN & RCP		
AB-22	134 FLOOR PLAN & RCP		
AB-23	133 FLOOR PLAN & RCP		

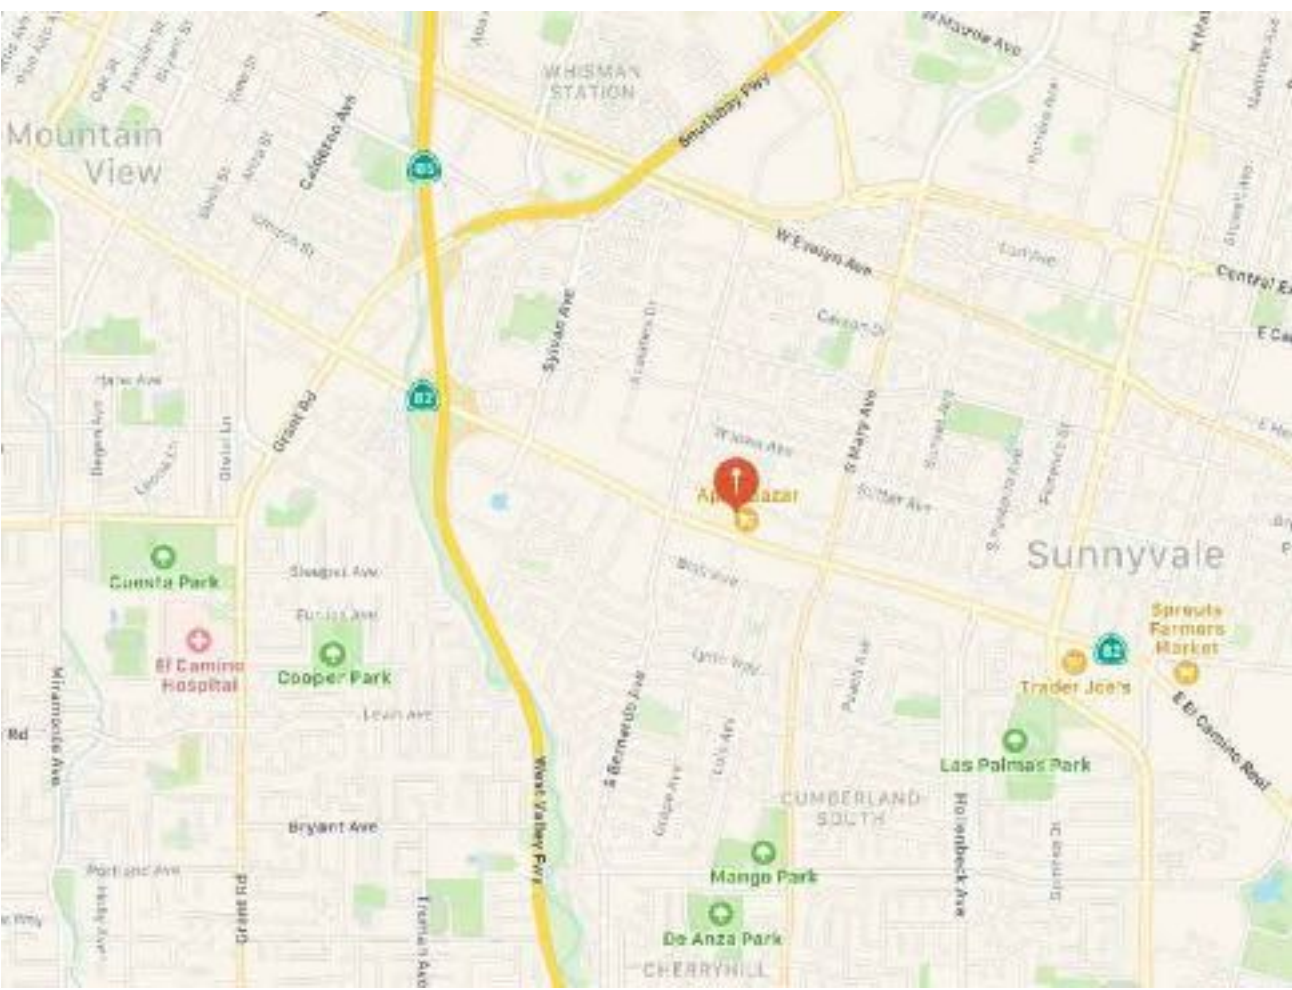

 **VICINITY MAP**
NTS

[illegible]

SL

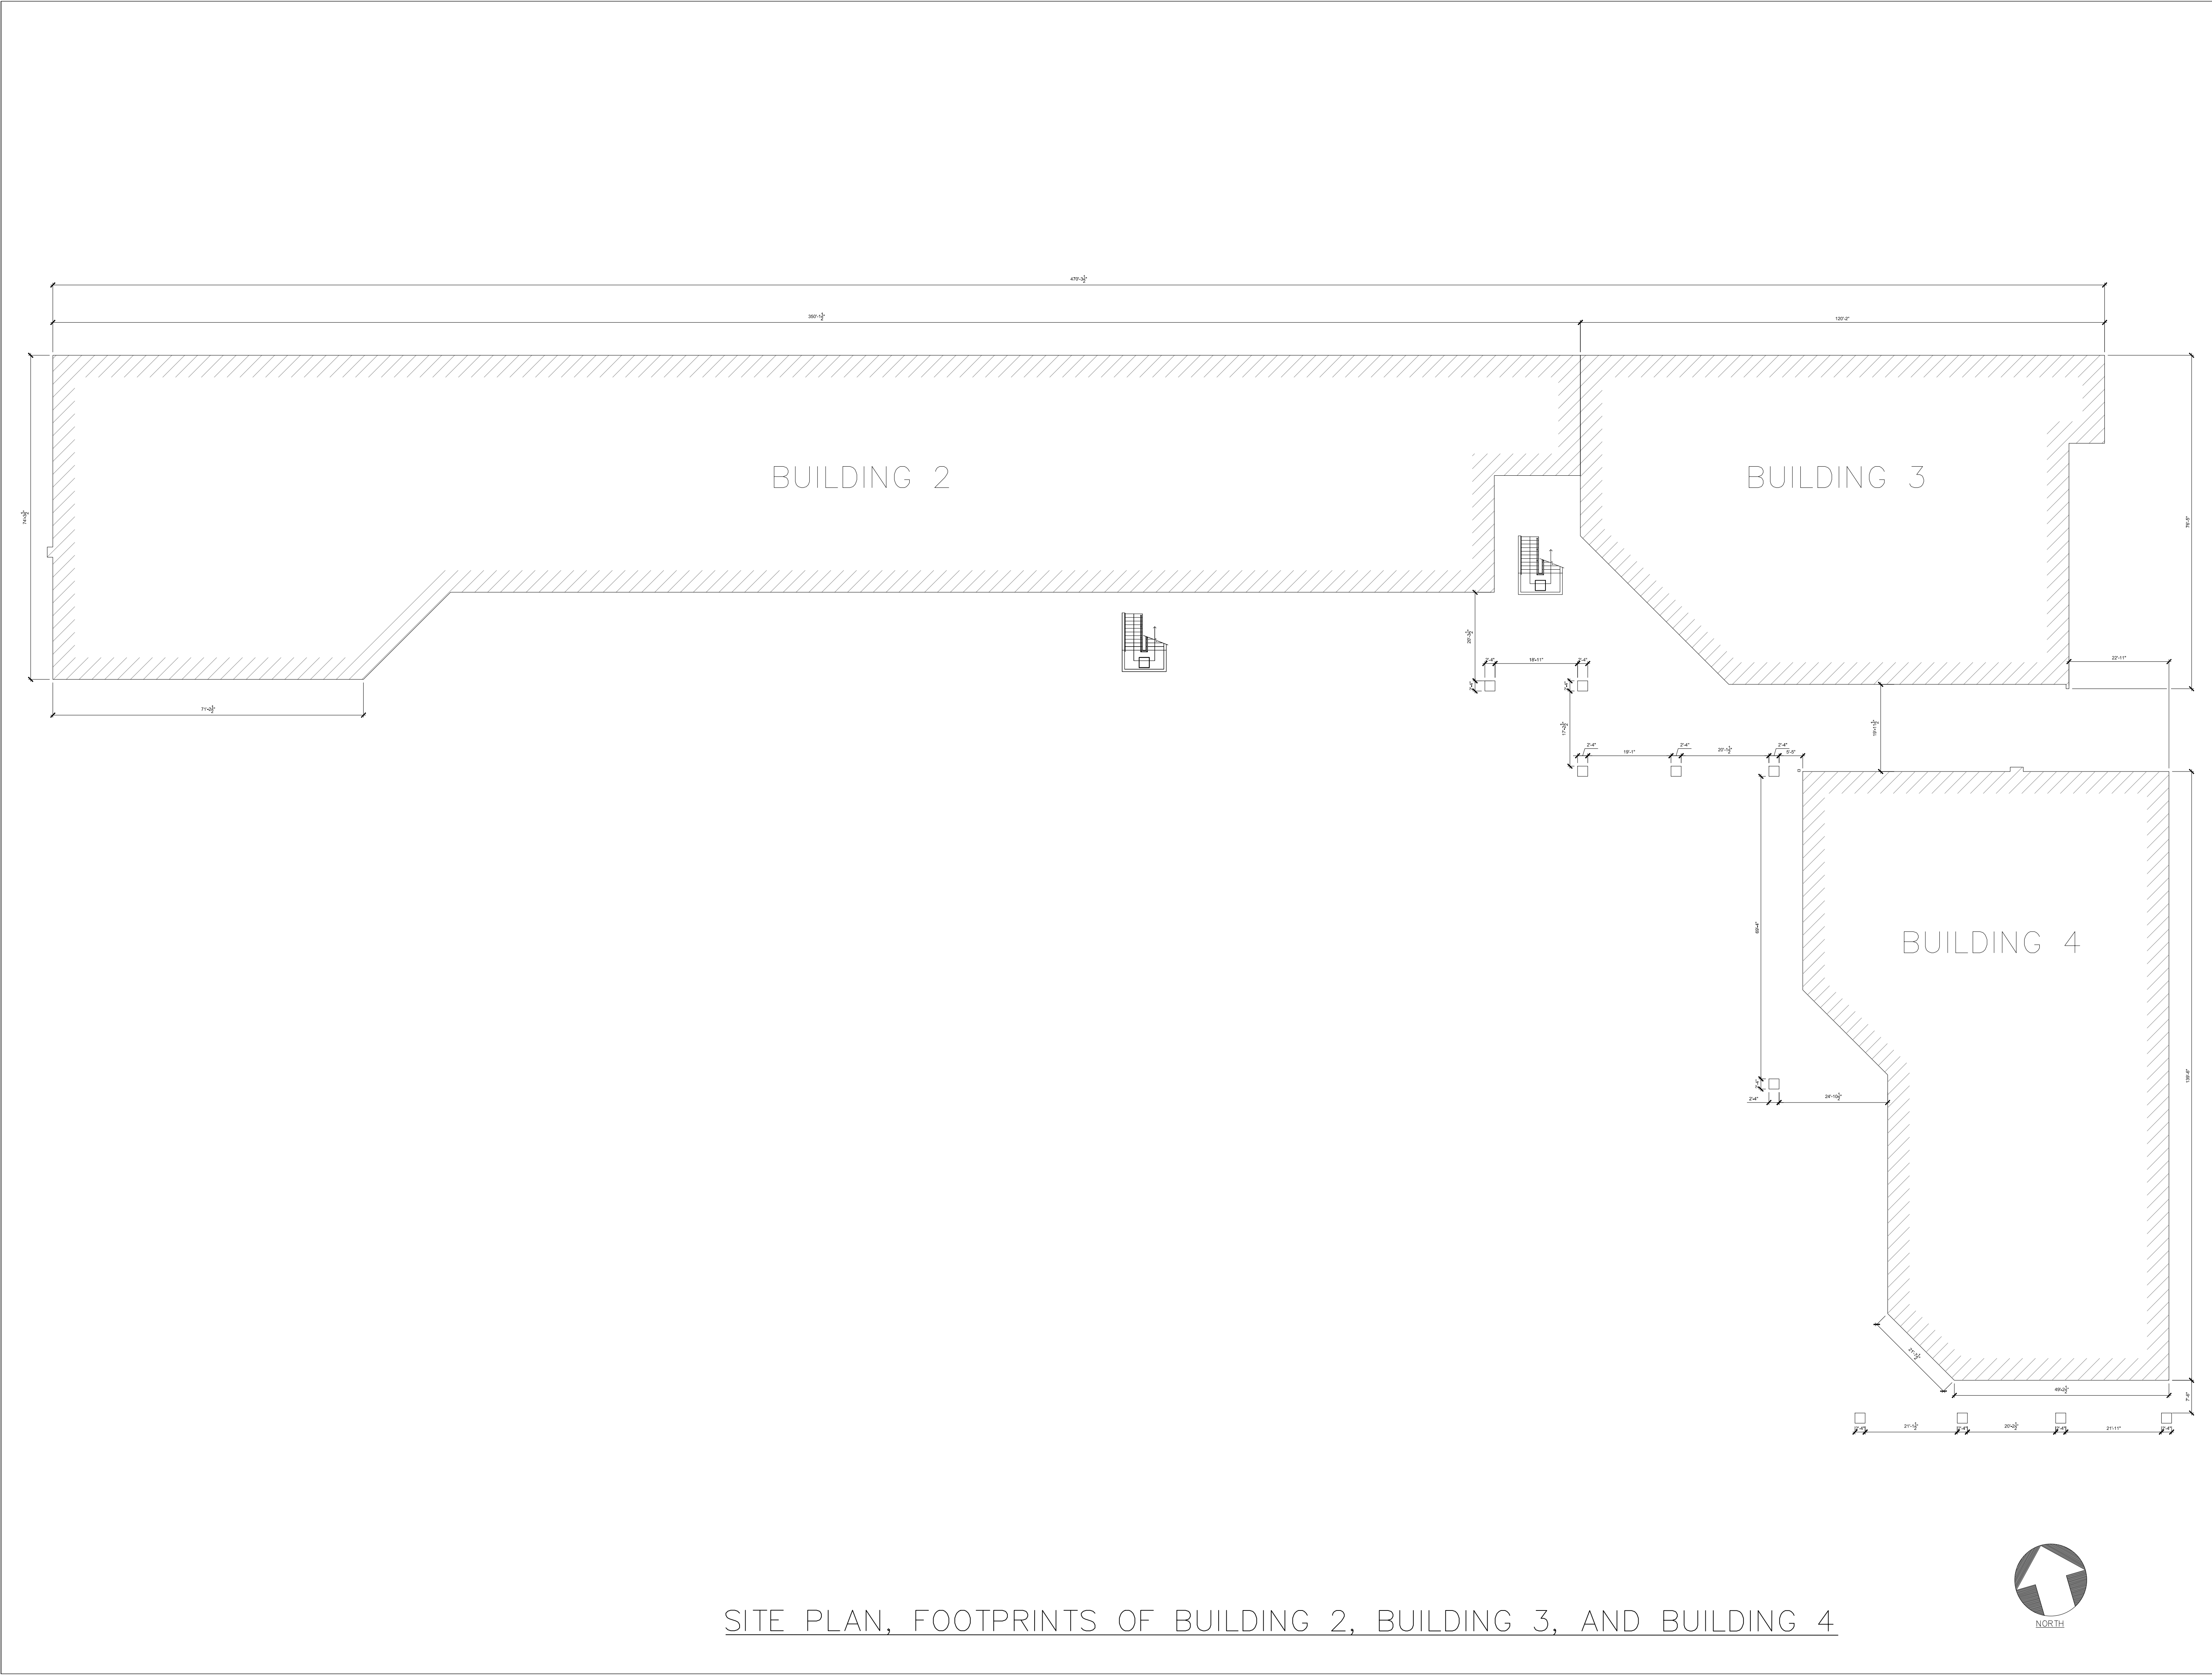

SITE PLAN, FOOTPRINTS OF BUILDING 2, BUILDING 3, AND BUILDING 4

ARCHITECTURAL AS BUILT





CALA CENTER

SUNNYVALE, CA 94087


1	REVISION	
NO.	ISSUES REVISIONS	DATE
SHEET TITLE		
SITE PLAN OF BUILDINGS 2, 3, AND 4		
HL	PROJECT MANAGER	
HL	PROJECT DIRECTOR	
	PROJECT NUMBER	
	SCALE	
1:200	DRAWN BY	
MM	SHEET NUMBER	

SP-1


- ☒ FLOOR PLANS DIMENSIONED
- ☒ TENANT DEMISING AND TENANT PARTITION WALLS
- ☒ WINDOWS, DOORS WITH (SIZES LABELED),
- ☒ BUILT-INS, COLUMNS,
- ☒ STRUCTURAL ELEMENTS SUCH AS
- ☒ DIAGONAL BRACING ,STAIRS
- ☒ ALL ROOF ACCESS LADDERS
- ☒ LABELING OF ALL ROOMS AND SPACES
- ☒ INDICATE OVERHANGS AND CANOPIES ABOVE AND NOTE HEIGHTS
- ☒ ALL COLUMNS ON THE OUTSIDE OF THE BUILDING
- ☒ SHOW MAJOR MEP ITEMS ON FLOORS AND WALLS
IE. BUILT-INS, TOILETS, SINKS, FLOOR DRAINS,
WATER HEATERS, AHU UNITS, (INSIDE THE
ENVELOPE).
- ☒ SHOW LOCATION OF ELECTRICAL PANELS (TAKE
- ☒ PICS OF PANEL AND DIRECTORY)
- ☒ FIRE SPRINKLER RISERS LOCATIONS AND MAIN PIPE
- ☒ DIAMETER SIZE (TAKE PICS OF RISER)
- ☒ INTERIOR HEIGHTS MEASURED TO BOTTOM OF
- ☒ STRUCTURE/TRUSS ONLY WHEN VISIBLE.

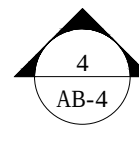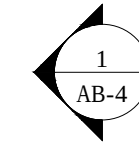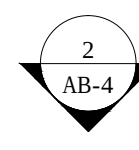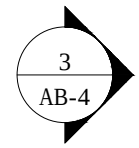

SCALE: $3/32'' = 1'-0''$

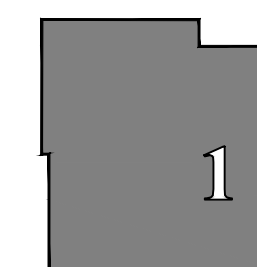

NORTH

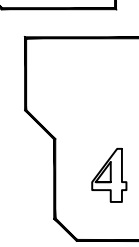

As BUILT

PROFESSIONALS

www.asbuiltprofessionals.com

A DIVISION OF:

AEC
CONSULTANTS INC.

844.272.8458
844 ASBUILT

© 2021 AEC CONSULTANTS INC.


ARCHITECTURAL AS BUILT

CALA CENTER


SUNNYVALE, CA 94087

1	REVISION	
NO.	ISSUES REVISIONS	DATE
SHEET TITLE		
BUILDING 1 FLOORPLAN		
H/L	PROJECT MANAGER	
H/L	PROJECT DIRECTOR	
		PROJECT NUMBER
3/32"=1'-0"		SCALE
MM	DRAWN BY	
SHEET NUMBER		
AB-1		

- SCOPE OF WORK: FLOORPLANS
- ✓ FLOOR PLANS DIMENSIONED
 - ✓ TENANT DEMISING AND TENANT PARTITION WALLS
 - ✓ WINDOWS, DOORS WITH (SIZES LABELED),
 - ✓ BUILT-INS, COLUMNS,
 - ✓ STRUCTURAL ELEMENTS SUCH AS
 - ✓ DIAGONAL BRACING ,STAIRS
 - ✓ ALL ROOF ACCESS LADDERS
 - ✓ LABELING OF ALL ROOMS AND SPACES
 - ✓ INDICATE OVERHANGS AND CANOPIES ABOVE AND NOTE HEIGHTS
 - ✓ ALL COLUMNS ON THE OUTSIDE OF THE BUILDING
 - ✓ SHOW MAJOR MEP ITEMS ON FLOORS AND WALLS
IE. BUILT-INS, TOILETS, SINKS, FLOOR DRAINS,
WATER HEATERS, AHU UNITS, (INSIDE THE
ENVELOPE).
 - ✓ SHOW LOCATION OF ELECTRICAL PANELS (TAKE
PICS OF PANEL AND DIRECTORY)
 - ✓ FIRE SPRINKLER RISERS LOCATIONS AND MAIN PIPE
 - ✓ DIAMETER SIZE (TAKE PICS OF RISER)
 - ✓ INTERIOR HEIGHTS MEASURED TO BOTTOM OF
STRUCTURE/TRUSS ONLY WHEN VISIBLE.

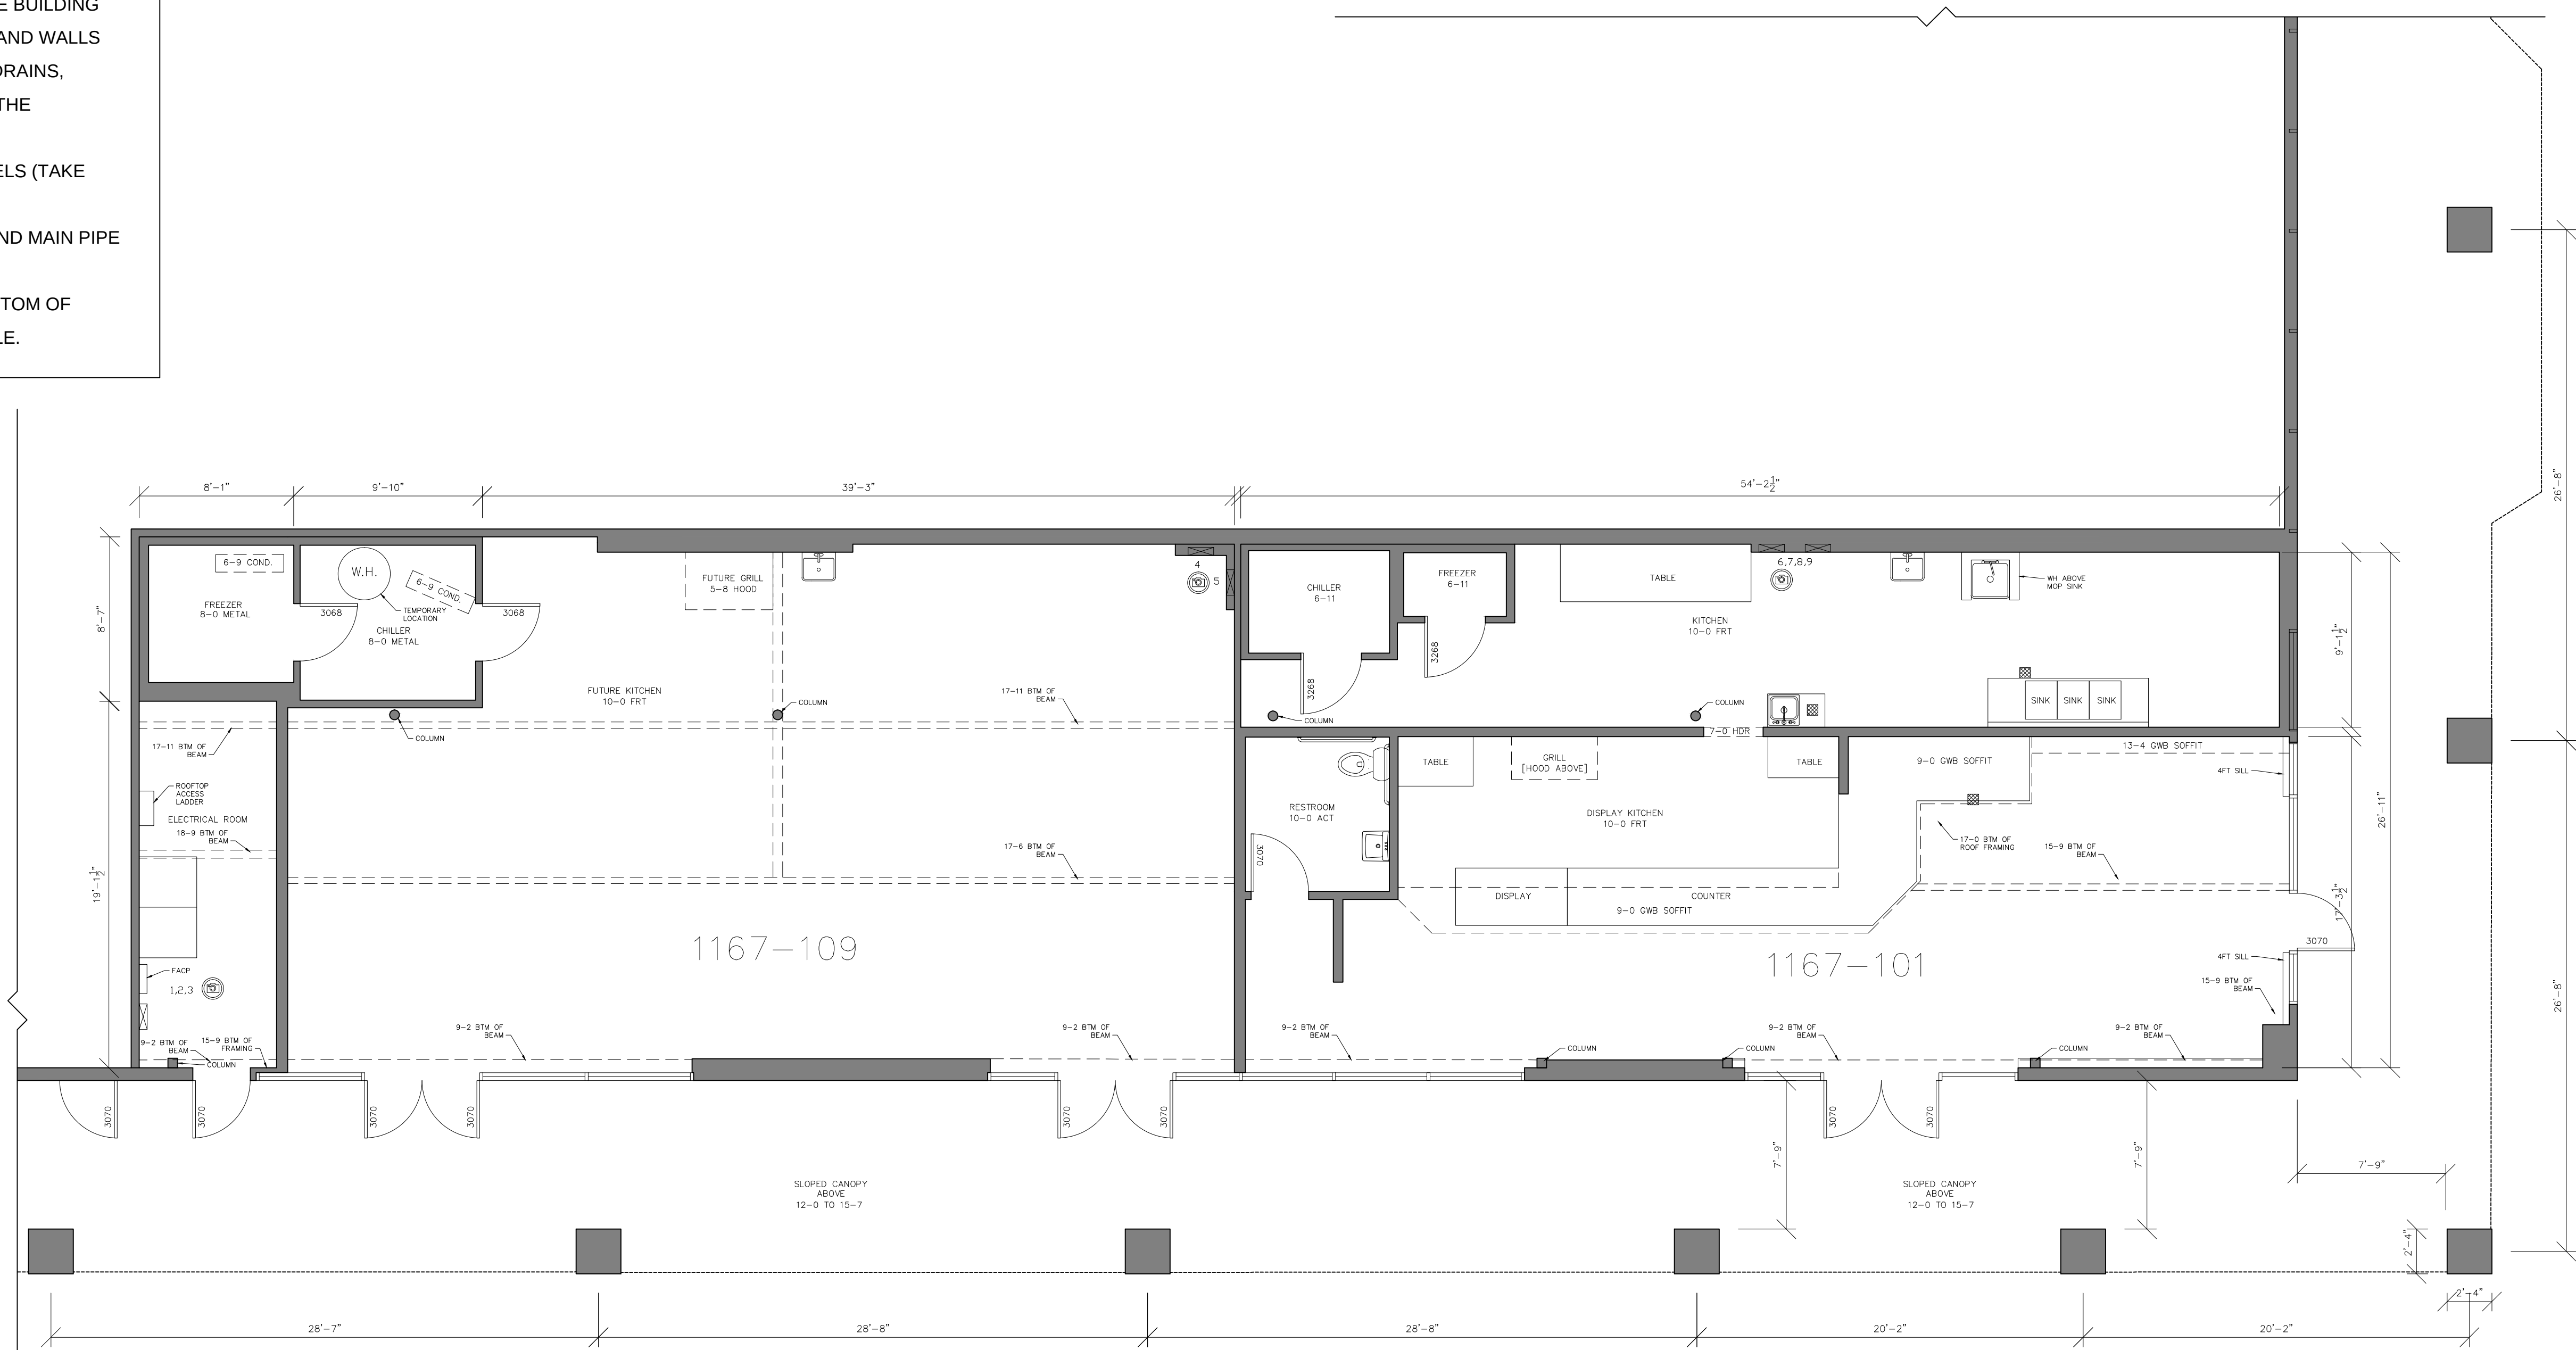

BUILDING 1 — ENLARGED FLOOR PLAN
SCALE: 3/16" = 1'-0"

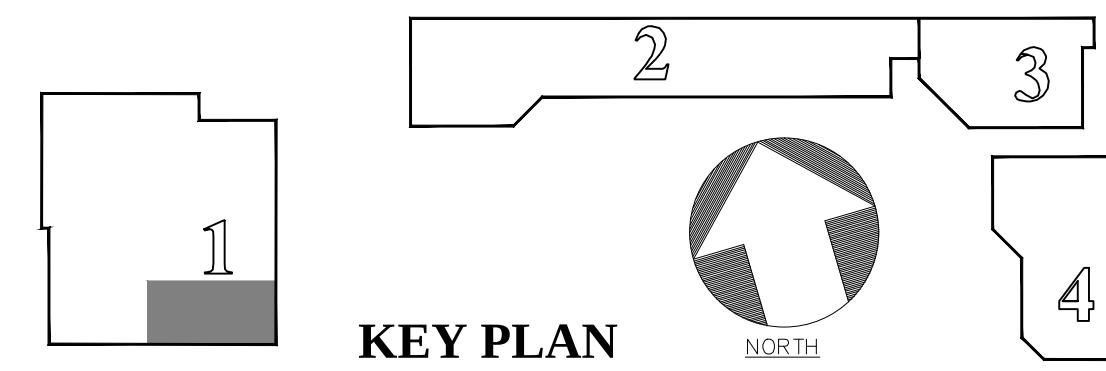

AS BUILT PROFESSIONALS
www.asbuiltprofessionals.com
A DIVISION OF:
AEC CONSULTANTS INC
844.272.8458
844 AS BUILT
© 2021 AEC CONSULTANTS INC


ARCHITECTURAL AS BUILT
CALA CENTER
SUNNYVALE, CA 94087

1	REVISION	
NO.	ISSUES REVISIONS	DATE
SHEET TITLE		
BUILDING 1 FLOORPLAN ENLARGED		
HL	PROJECT MANAGER	
HL	PROJECT DIRECTOR	
	PROJECT NUMBER	
	SCALE	
MM	DRAWN BY	
	SHEET NUMBER	

AB-2


SCOPE OF WORK: ROOF PLAN

- ✓ ROOF OUTLINE INCLUDING VALLEYS
- ✓ RIDGES
- ✓ HIPS
- ✓ SLOPE DIRECTION (SHOW WITH ARROWS AND GRADE %)
- ✓ DRAINAGE (ROOF DRAIN / OVERFLOW DRAINS)
- ✓ PARAPET WALLS
- ✓ SKYLIGHTS
- ✓ CHIMNEYS
- ✓ RTU'S AND ANY EQUIPMENT
- ✓ LOCATIONS OF ANY PLUMBING RUNNING ALONG THE ROOF (E.G. GAS)
- ✓ BUILDING LINE
- ✓ PROVIDE ELEVATION POINTS FOR ROOF SURFACE, INCLUDING TOP OF PARAPET, VALLEYS, DRAINS AND RIDGES.

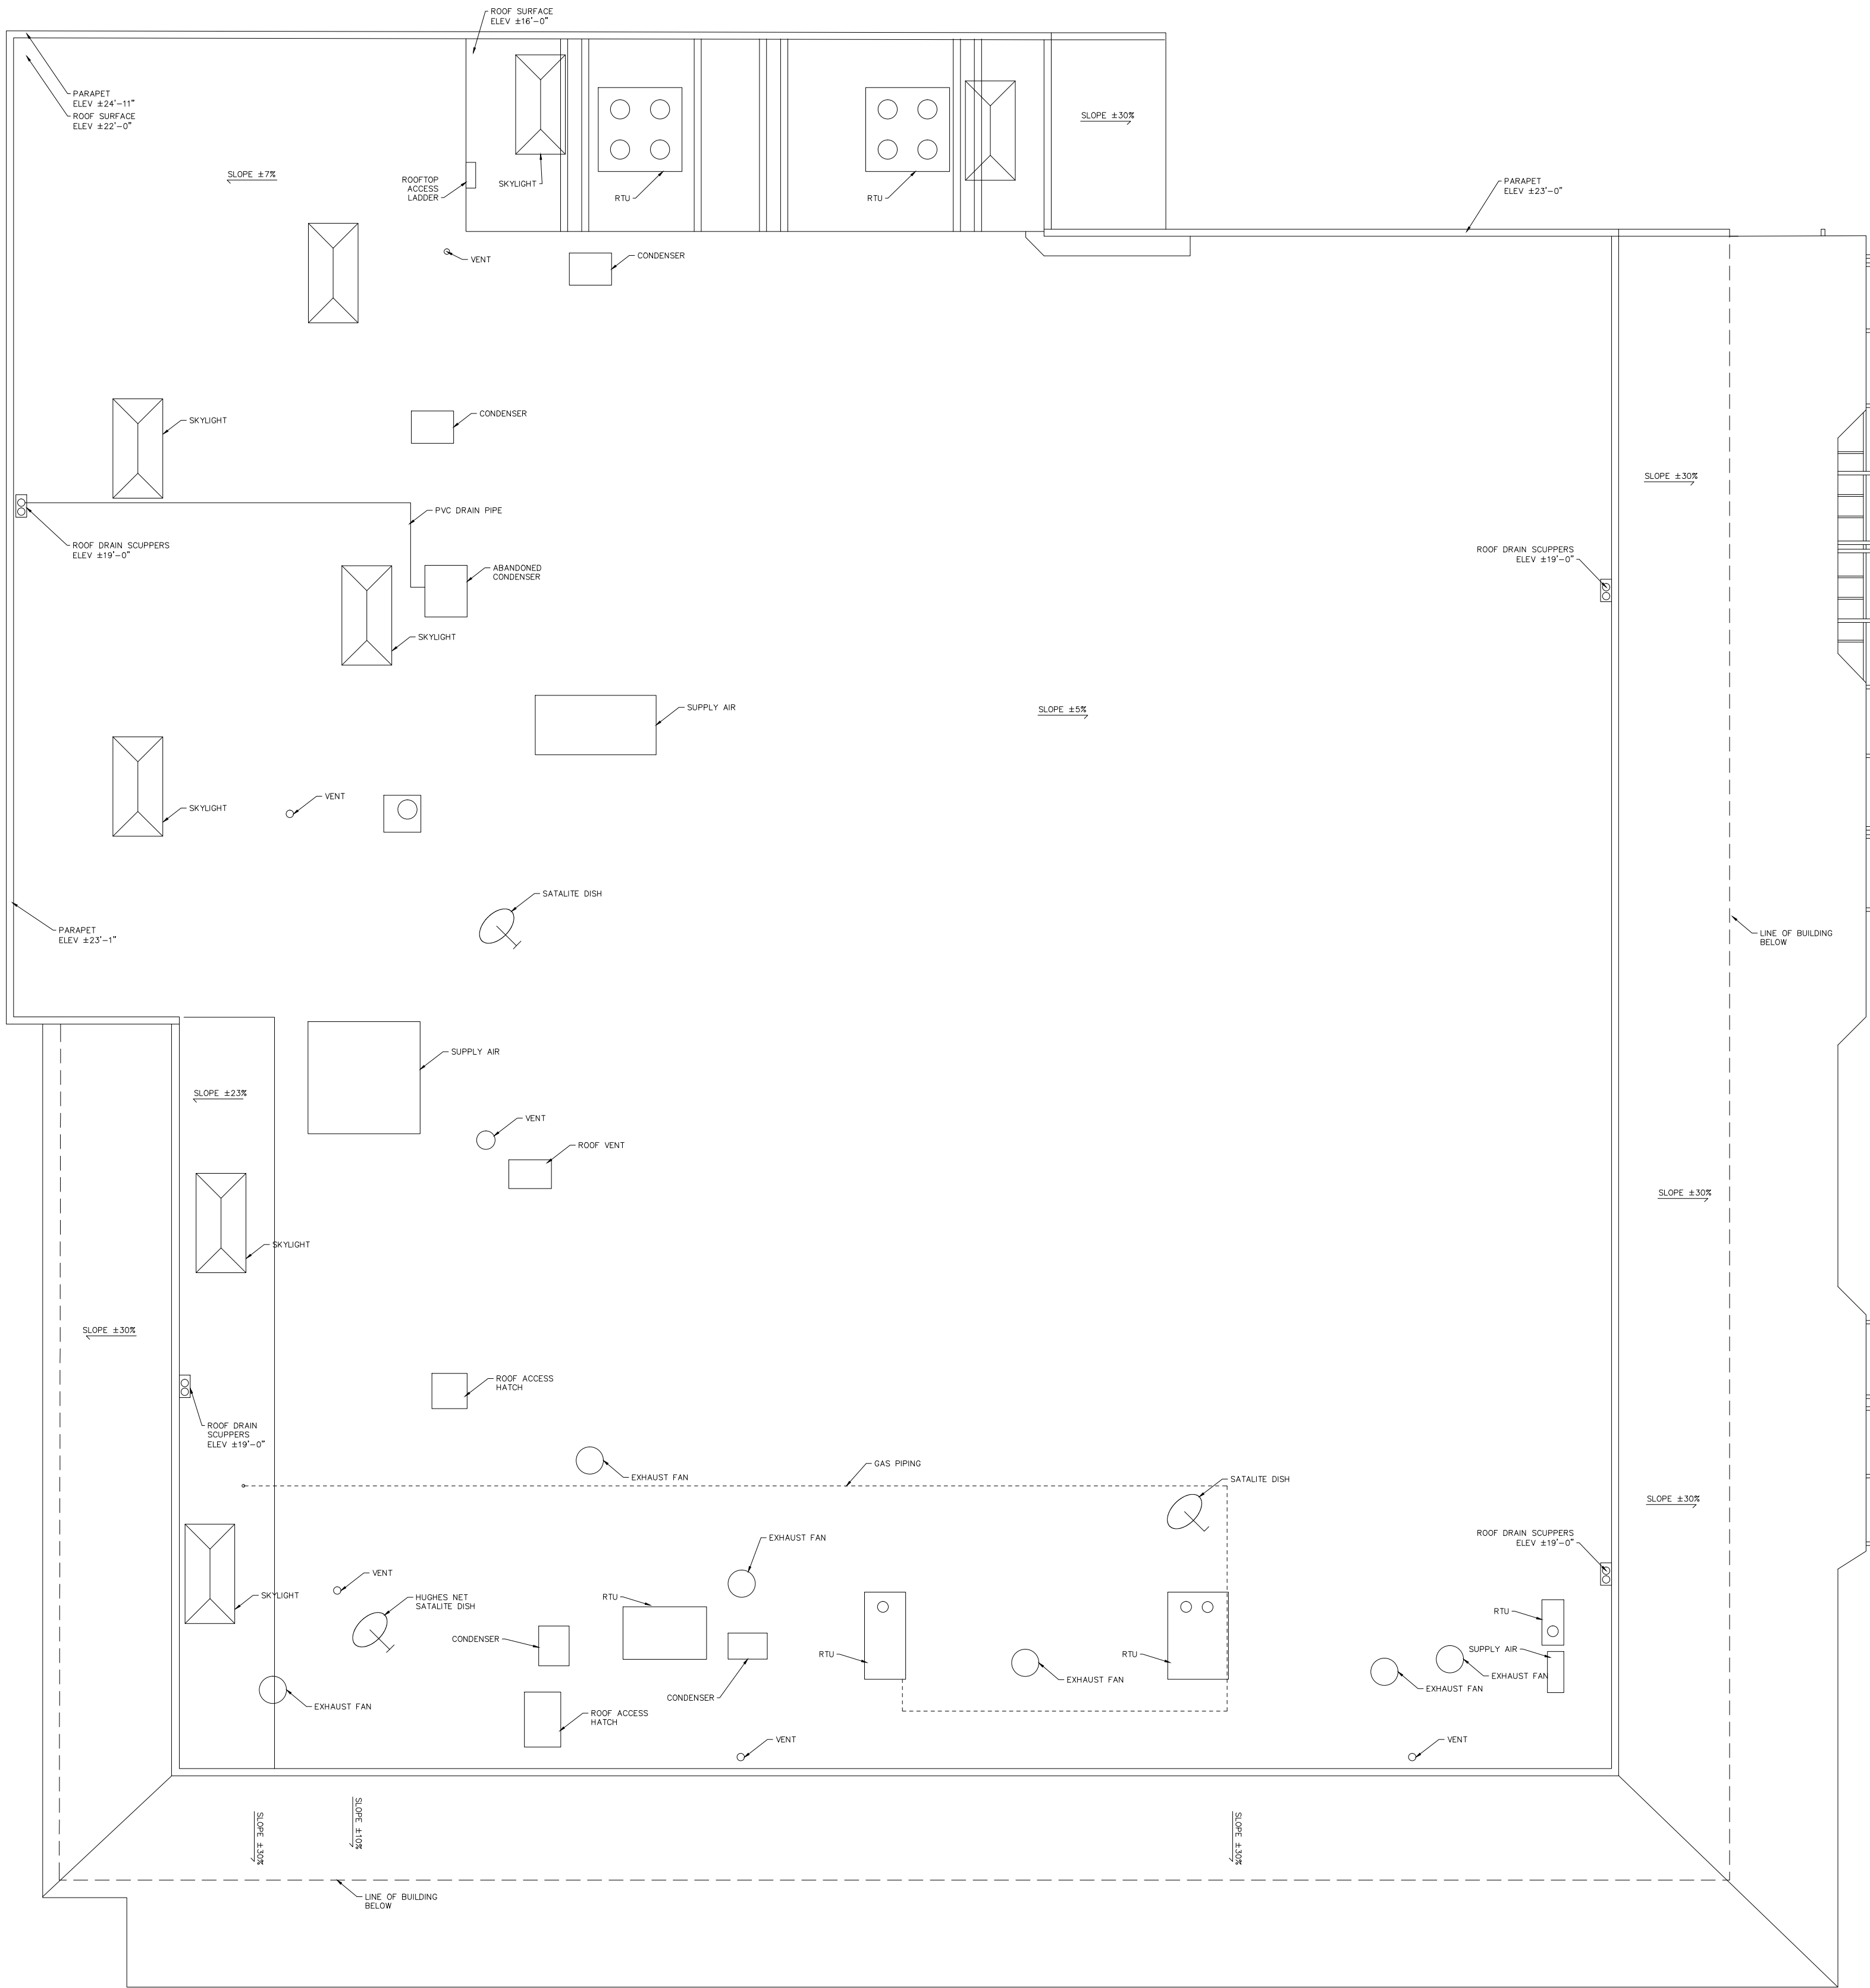


BUILDING 1 — ROOF PLAN

SCALE: 3/32" = 1'-0"

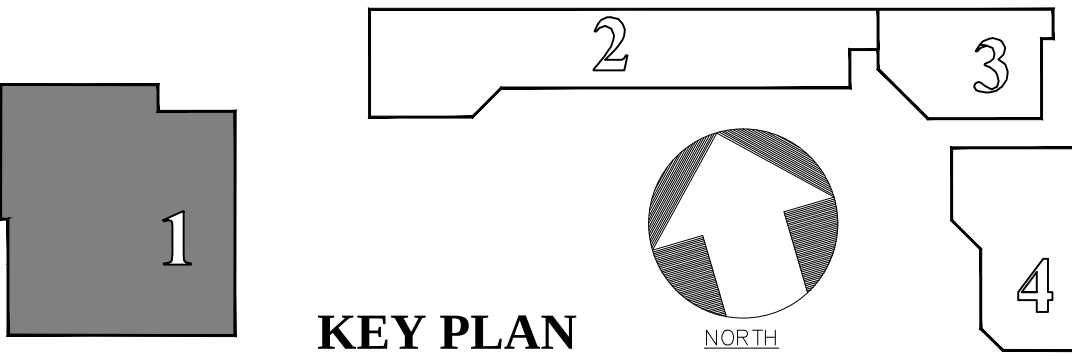

KEY PLAN

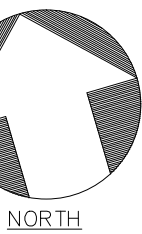


AS BUILT
PROFESSIONALS
www.asbuiltprofessionals.com
A DIVISION OF:
AEC
CONSULTANTS INC
844.272.8458
844 AS BUILT
© 2021 AEC CONSULTANTS INC

ARCHITECTURAL AS BUILT
CALA CENTER
SUNNYVALE, CA 94087


1	REVISION	
NO.	ISSUES REVISIONS	DATE
SHEET TITLE		
BUILDING 1 ROOFPLAN		
HL	PROJECT MANAGER	
HL	PROJECT DIRECTOR	
	PROJECT NUMBER	
	SCALE	
3/32"=1'-0"	DRAWN BY	
MM	SHEET NUMBER	

AB-3

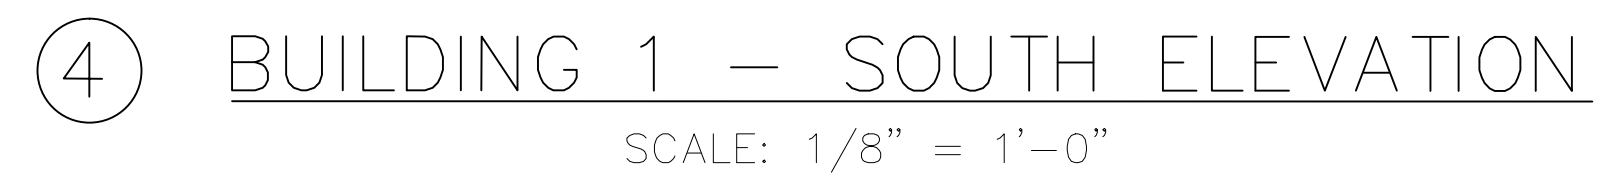


AB-4

- ☒ FLOOR PLANS DIMENSIONED
- ☒ TENANT DEMISING AND TENANT PARTITION WALLS
- ☒ WINDOWS, DOORS WITH (SIZES LABELED),
- ☒ BUILT-INS, COLUMNS,
- ☒ STRUCTURAL ELEMENTS SUCH AS
- ☒ DIAGONAL BRACING , STAIRS
- ☒ ALL ROOF ACCESS LADDERS
- ☒ LABELING OF ALL ROOMS AND SPACES
- ☒ INDICATE OVERHANGS AND CANOPIES ABOVE AND NOTE HEIGHTS
- ☒ ALL COLUMNS ON THE OUTSIDE OF THE BUILDING
- ☒ SHOW MAJOR MEP ITEMS ON FLOORS AND WALLS
IE. BUILT-INS, TOILETS, SINKS, FLOOR DRAINS,
WATER HEATERS, AHU UNITS, (INSIDE THE ENVELOPE).
- ☒ SHOW LOCATION OF ELECTRICAL PANELS (TAKE
- ☒ PICS OF PANEL AND DIRECTORY)
- ☒ FIRE SPRINKLER RISERS LOCATIONS AND MAIN PIPE
- ☒ DIAMETER SIZE (TAKE PICS OF RISER)
- ☒ INTERIOR HEIGHTS MEASURED TO BOTTOM OF
- ☒ STRUCTURE/TRUSS ONLY WHEN VISIBLE.

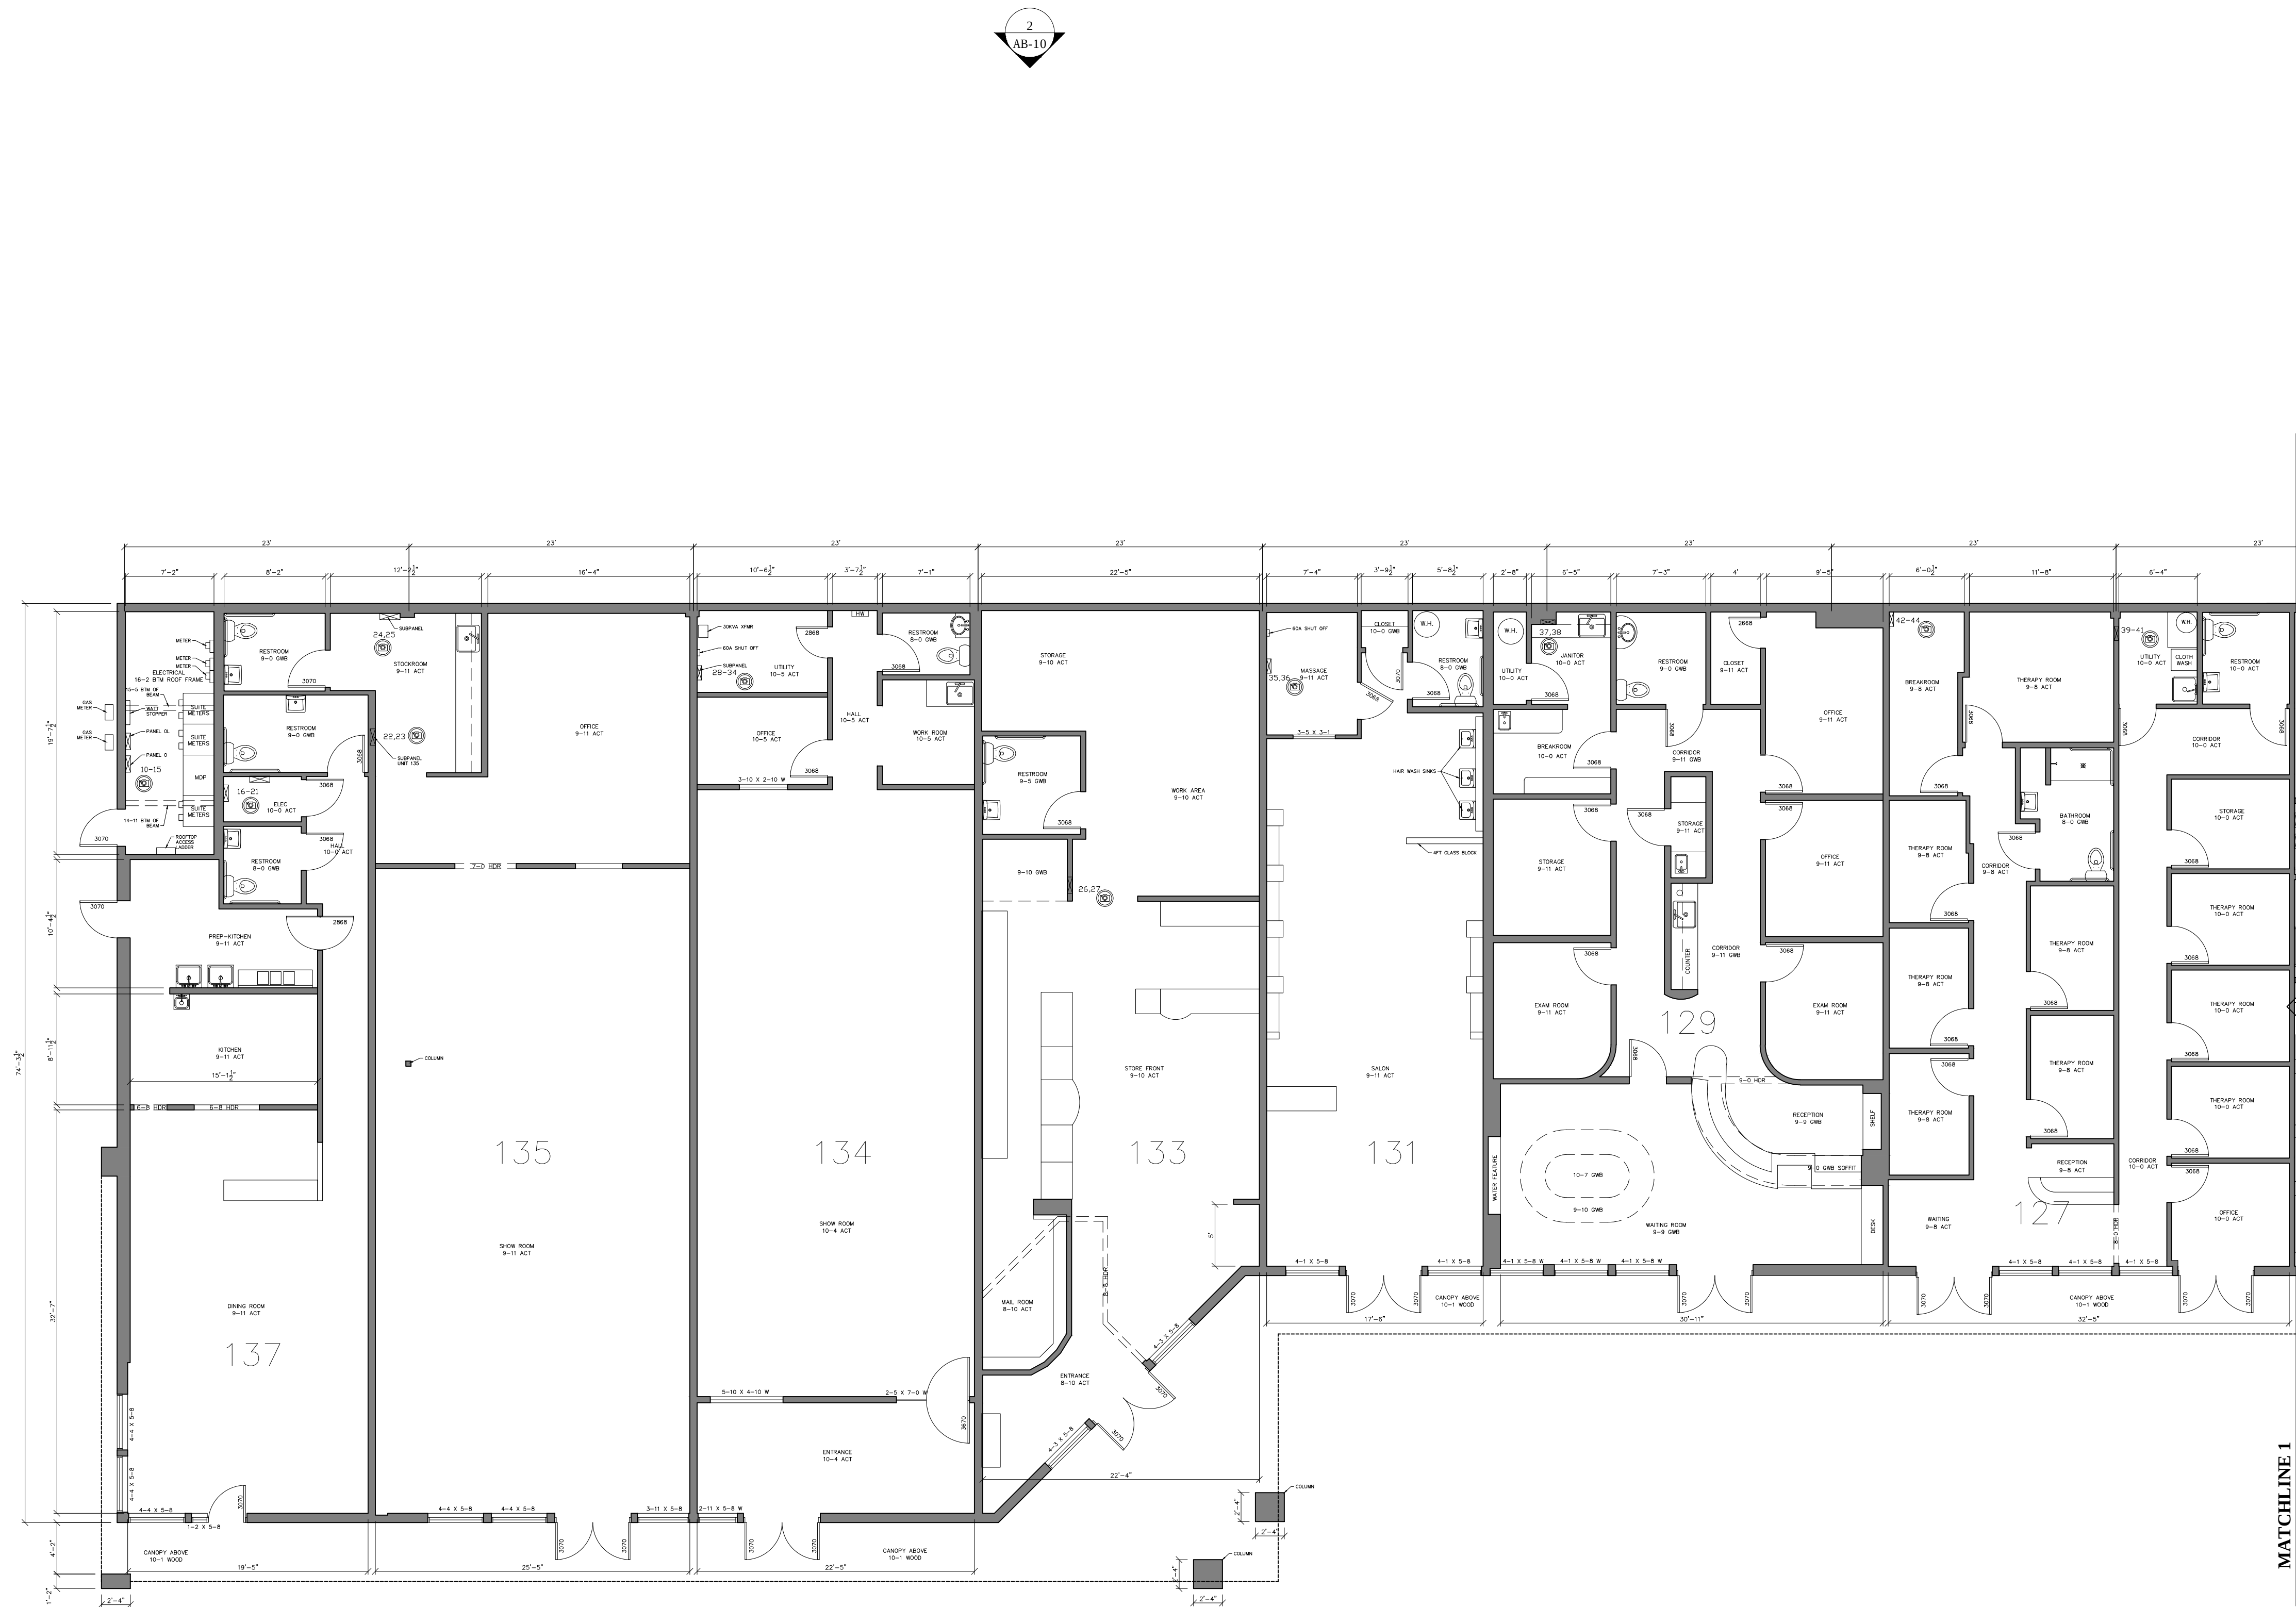

BUILDING 2 – GROUND FLOOR PLAN
SCALE: 1/8" = 1'-0"

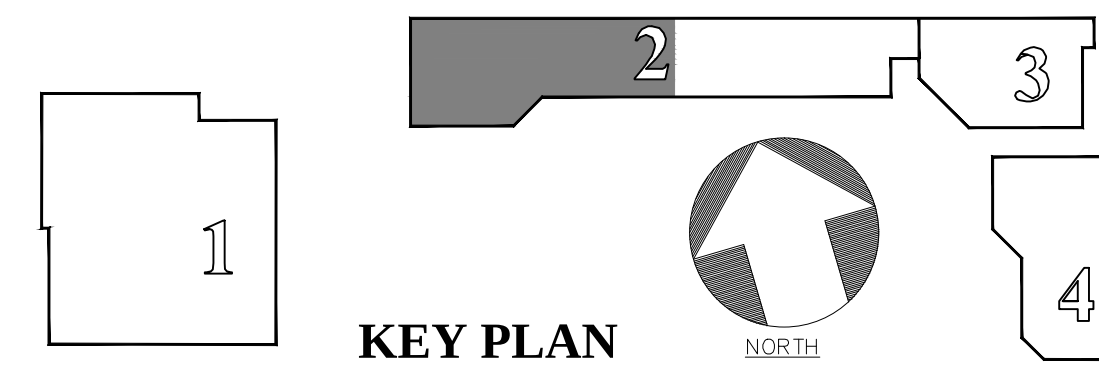

ARCHITECTURAL AS BUILT
CALA CENTER
SUNNYVALE, CA 94087


1	REVISION	
NO.	ISSUES REVISIONS	DATE

BUILDING 2 FLOORPLAN

HL	PROJECT MANAGER
HL	PROJECT DIRECTOR
	PROJECT NUMBER
1/8"=1'-0"	SCALE
MM	DRAWN BY
	SHEET NUMBER


AB-5

- ☒ FLOOR PLANS DIMENSIONED
- ☒ TENANT DEMISING AND TENANT PARTITION WALLS
- ☒ WINDOWS, DOORS WITH (SIZES LABELED),
- ☒ BUILT-INS, COLUMNS,
- ☒ STRUCTURAL ELEMENTS SUCH AS
- ☒ DIAGONAL BRACING ,STAIRS
- ☒ ALL ROOF ACCESS LADDERS
- ☒ LABELING OF ALL ROOMS AND SPACES
- ☒ INDICATE OVERHANGS AND CANOPIES ABOVE AND NOTE HEIGHTS
- ☒ ALL COLUMNS ON THE OUTSIDE OF THE BUILDING
- ☒ SHOW MAJOR MEP ITEMS ON FLOORS AND WALLS
IE. BUILT-INS, TOILETS, SINKS, FLOOR DRAINS,
WATER HEATERS, AHU UNITS, (INSIDE THE ENVELOPE).
- ☒ SHOW LOCATION OF ELECTRICAL PANELS (TAKE
- ☒ PICS OF PANEL AND DIRECTORY)
- ☒ FIRE SPRINKLER RISERS LOCATIONS AND MAIN PIPE
- ☒ DIAMETER SIZE (TAKE PICS OF RISER)
- ☒ INTERIOR HEIGHTS MEASURED TO BOTTOM OF
- ☒ STRUCTURE/TRUSS ONLY WHEN VISIBLE.

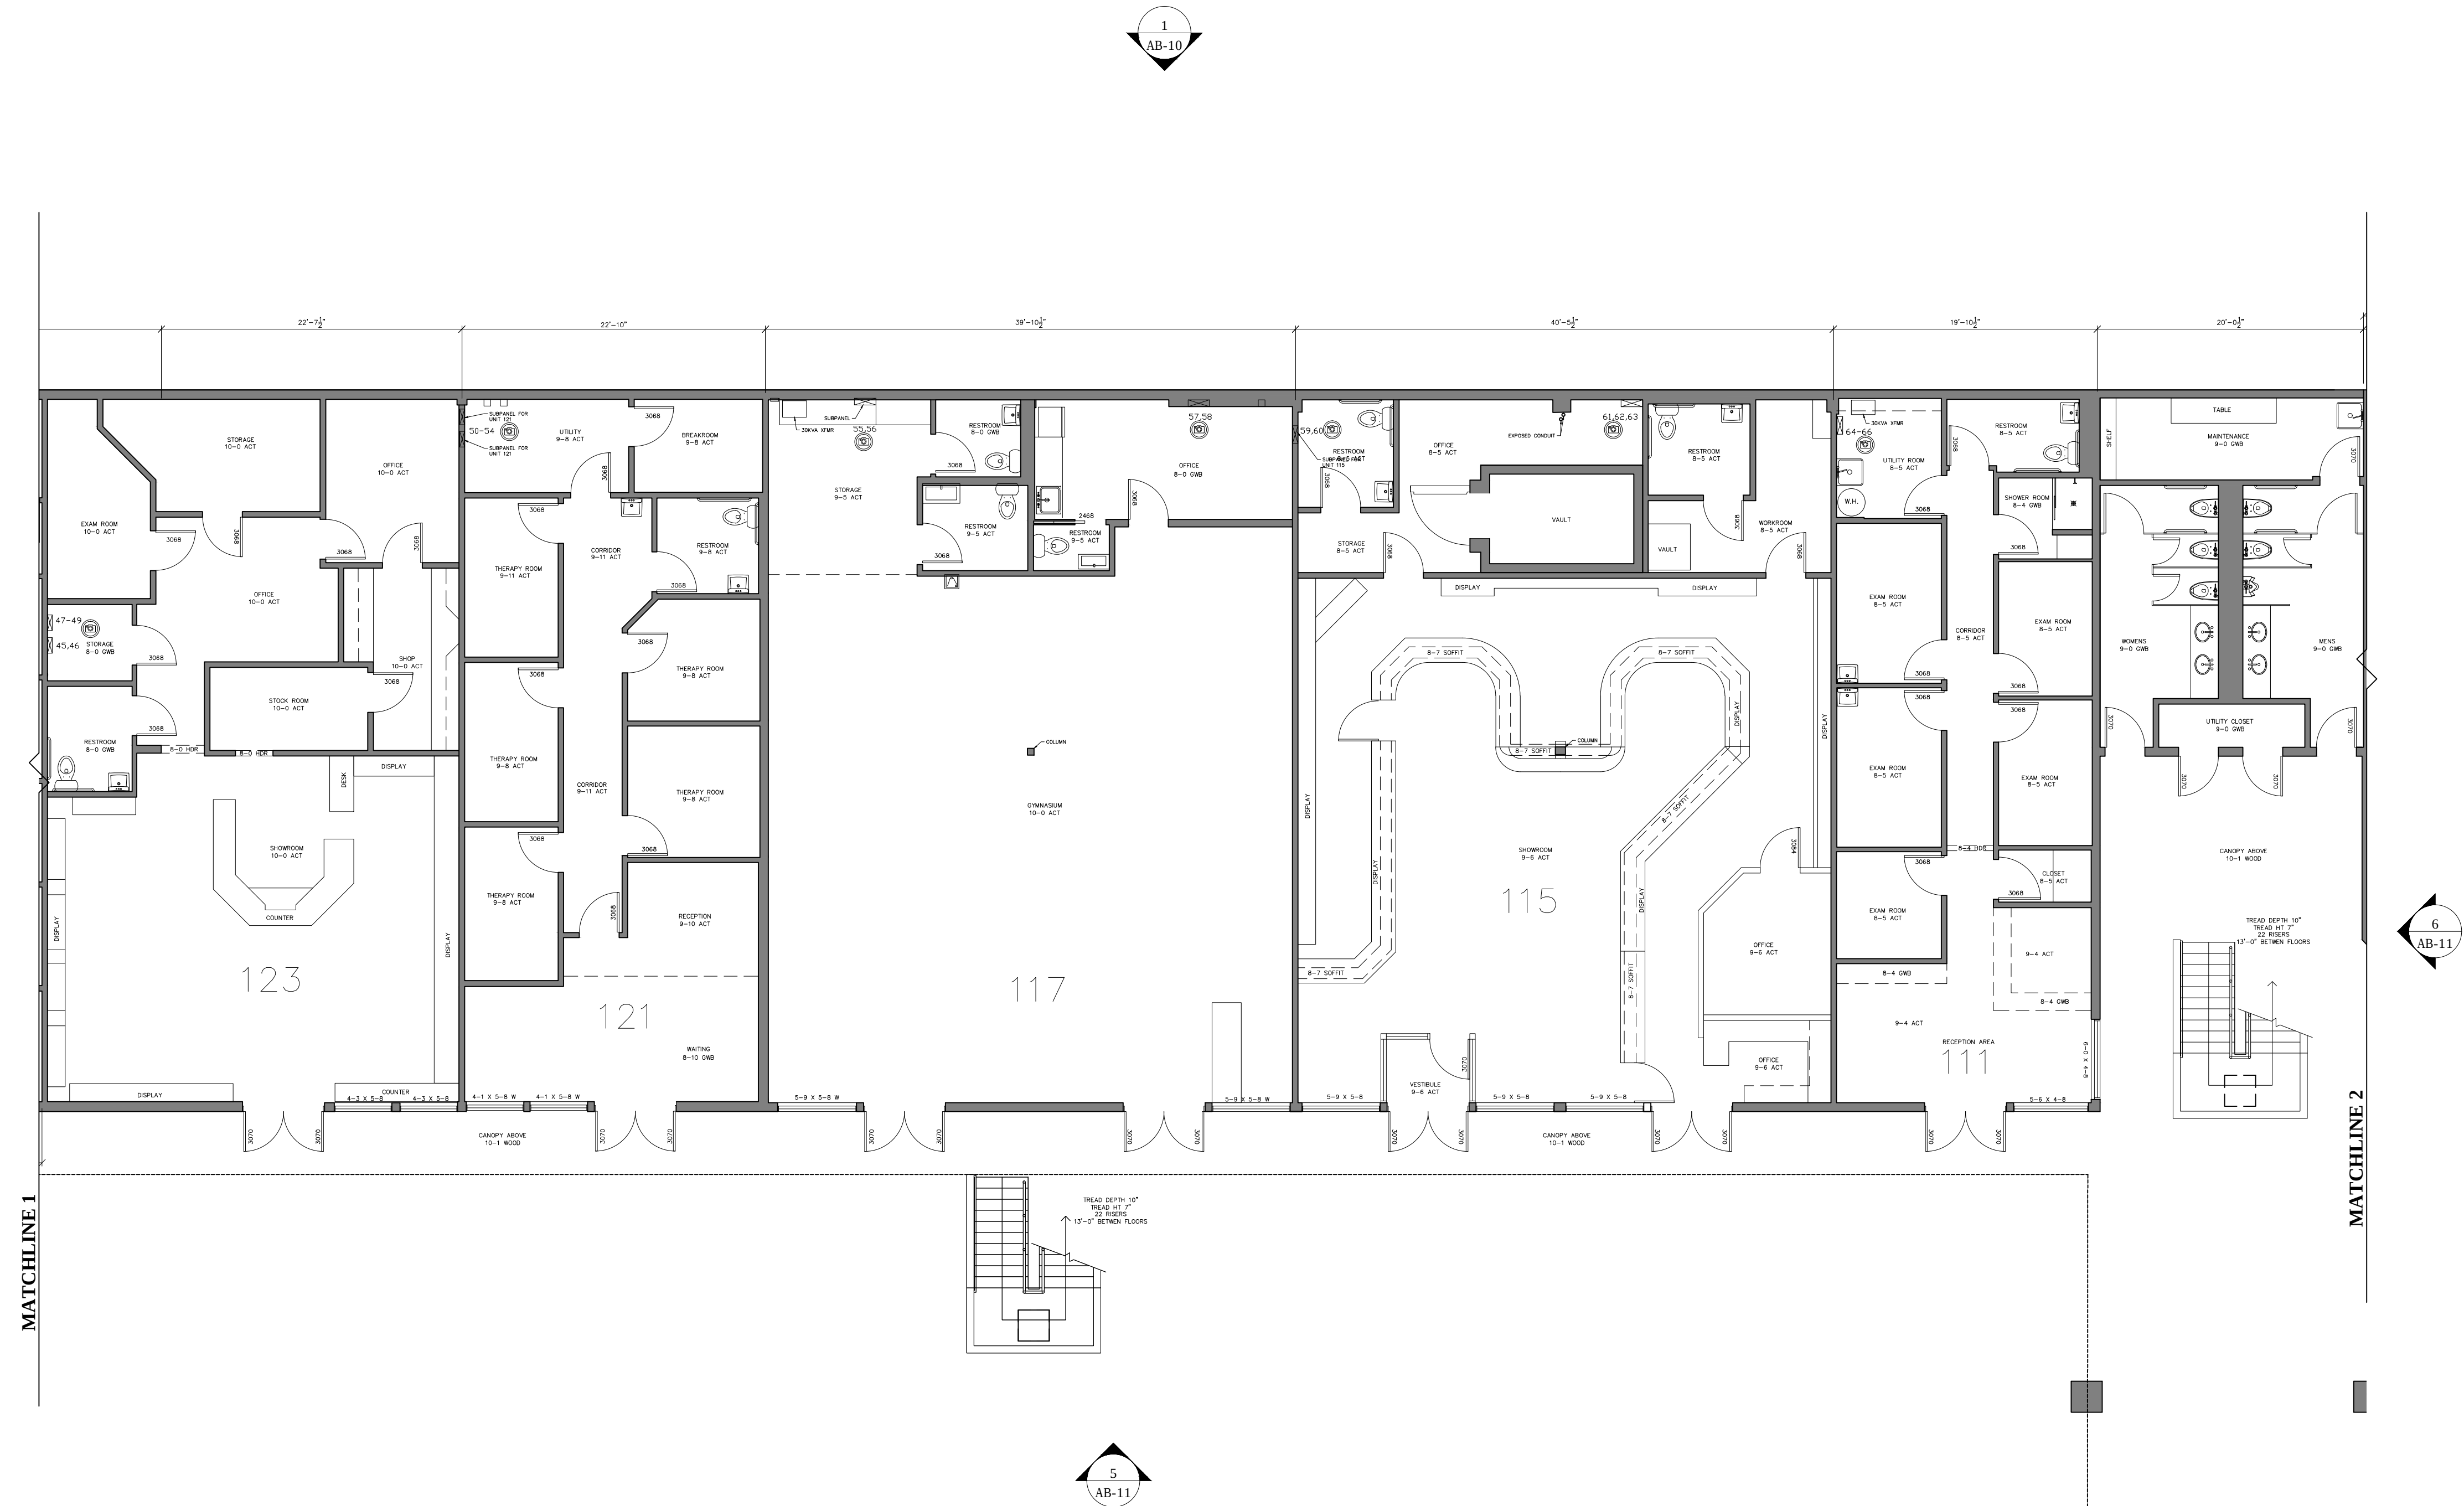

BUILDING 2 – GROUND FLOOR PLAN



SCALE: 1/8" = 1'-0"

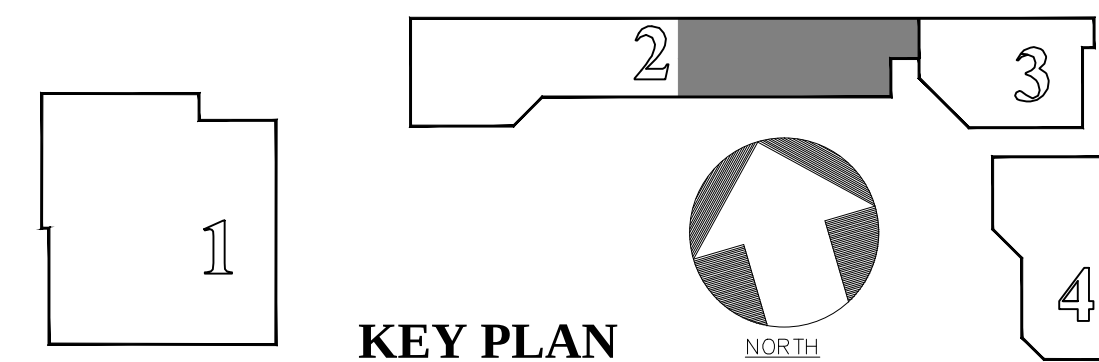

ARCHITECTURAL AS BUILT
CALA CENTER
SUNNYVALE, CA 94087


[illegible]

- SCOPE OF WORK: FLOORPLANS
- ✓ FLOOR PLANS DIMENSIONED
 - ✓ TENANT DEMISING AND TENANT PARTITION WALLS
 - ✓ WINDOWS, DOORS WITH (SIZES LABELED),
 - ✓ BUILT-INS, COLUMNS,
 - ✓ STRUCTURAL ELEMENTS SUCH AS
 - ✓ DIAGONAL BRACING ,STAIRS
 - ✓ ALL ROOF ACCESS LADDERS
 - ✓ LABELING OF ALL ROOMS AND SPACES
 - ✓ INDICATE OVERHANGS AND CANOPIES ABOVE AND NOTE HEIGHTS
 - ✓ ALL COLUMNS ON THE OUTSIDE OF THE BUILDING
 - ✓ SHOW MAJOR MEP ITEMS ON FLOORS AND WALLS
IE. BUILT-INS, TOILETS, SINKS, FLOOR DRAINS,
WATER HEATERS, AHU UNITS, (INSIDE THE
ENVELOPE).
 - ✓ SHOW LOCATION OF ELECTRICAL PANELS (TAKE
✓ PICS OF PANEL AND DIRECTORY)
 - ✓ FIRE SPRINKLER RISERS LOCATIONS AND MAIN PIPE
 - ✓ DIAMETER SIZE (TAKE PICS OF RISER)
 - ✓ INTERIOR HEIGHTS MEASURED TO BOTTOM OF
 - ✓ STRUCTURE/TRUSS ONLY WHEN VISIBLE.

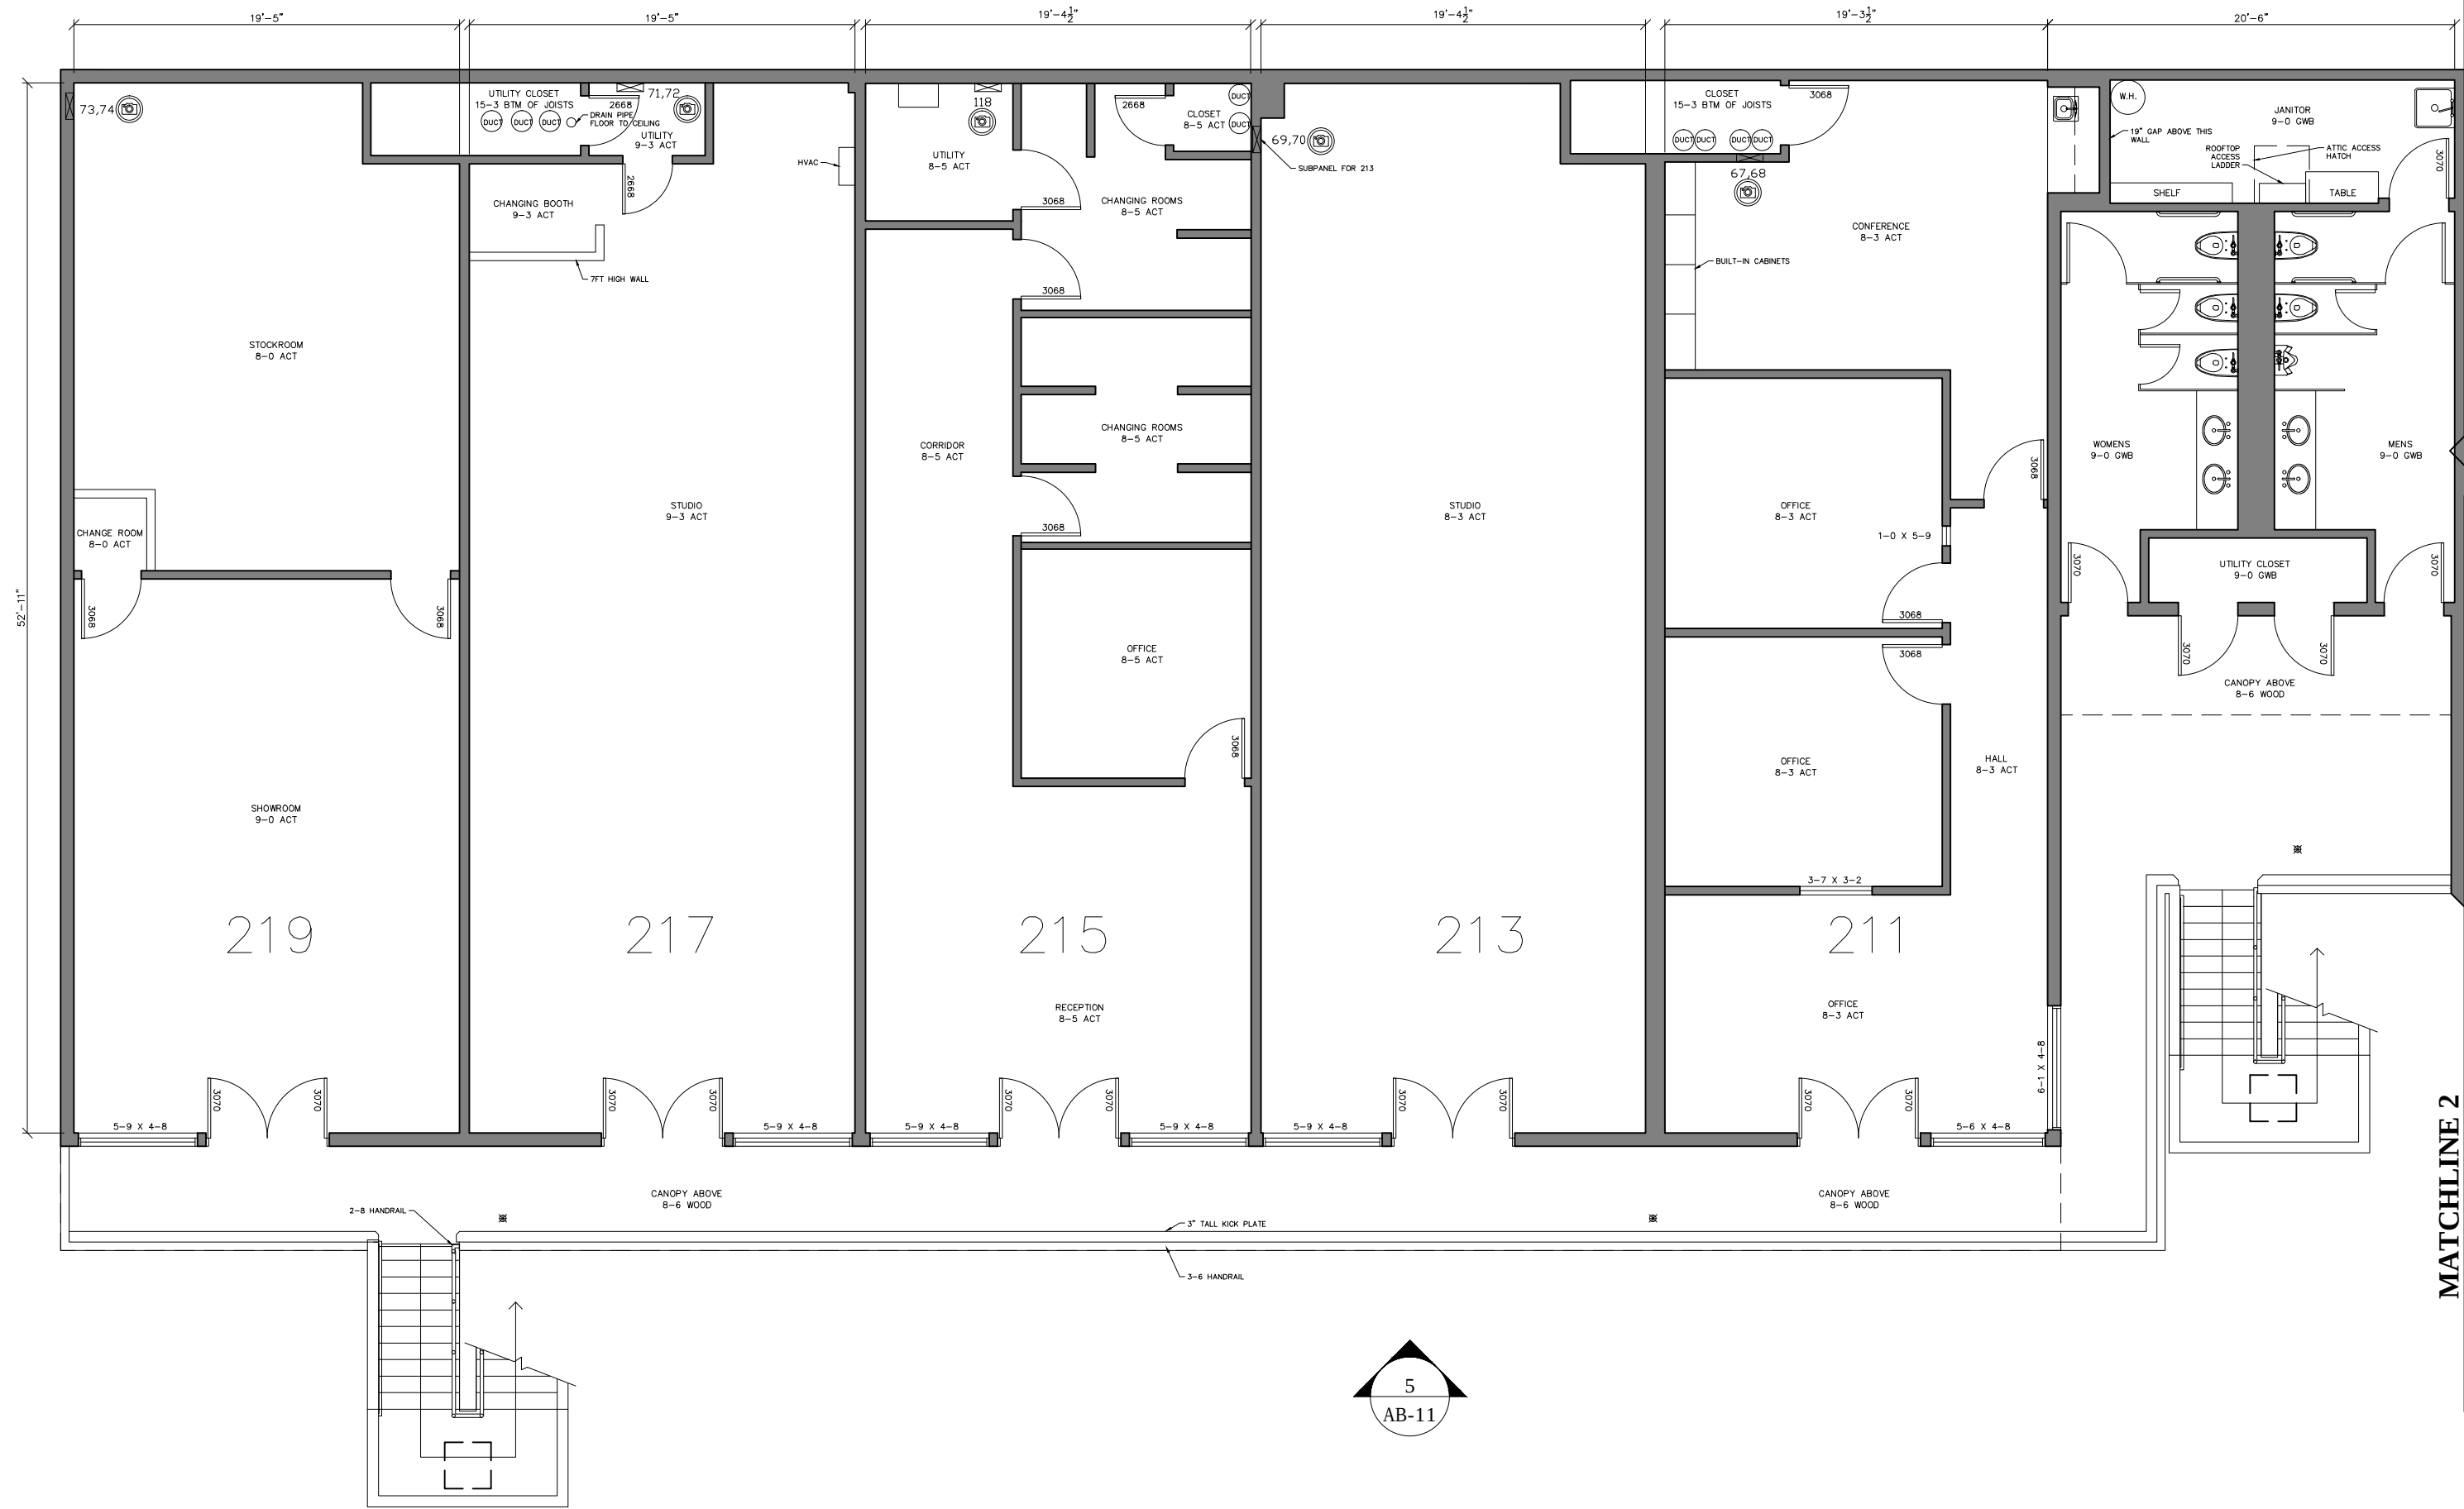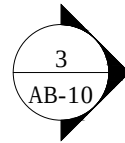

BUILDING 2 – SECOND FLOOR PLAN

SCALE: 1/8" = 1'-0"

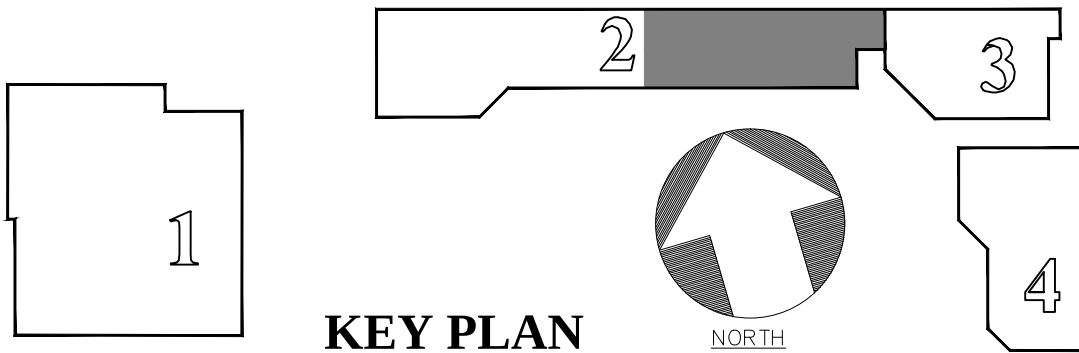

AS BUILT
PROFESSIONALS
www.asbuiltprofessionals.com
A DIVISION OF:

AEC
CONSULTANTS INC

844.272.8458
844 AS BUILT



© 2021 AEC CONSULTANTS INC

ARCHITECTURAL AS BUILT
CALA CENTER
SUNNYVALE, CA 94087

1	REVISION	
NO.	ISSUES REVISIONS	DATE
SHEET TITLE		
BUILDING 2 FLOORPLAN SECOND FLOOR		
HL	PROJECT MANAGER	
HL	PROJECT DIRECTOR	
	PROJECT NUMBER	
	SCALE	
MM	DRAWN BY	
	SHEET NUMBER	

AB-7



- ☒ ROOF OUTLINE INCLUDING VALLEYS
- ☒ RIDGES
- ☒ HIPS
- ☒ SLOPE DIRECTION (SHOW WITH ARROWS)
- ☒ AND GRADE (%)
- ☒ DRAINAGE (ROOF DRAIN / OVERFLOW
- ☒ DRAINS)
- ☒ PARAPET WALLS
- ☒ SKYLIGHTS
- ☒ CHIMNEYS
- ☒ RTU'S AND ANY EQUIPMENT
- ☒ LOCATIONS OF ANY PLUMBING RUNNING
- ☒ ALONG THE ROOF (E.G. GAS)
- ☒ BUILDING LINE
- ☒ PROVIDE ELEVATION POINTS FOR ROOF
- ☒ SURFACE, INCLUDING TOP OF PARAPET,
- ☒ VALLEYS, DRAINS AND RIDGES.

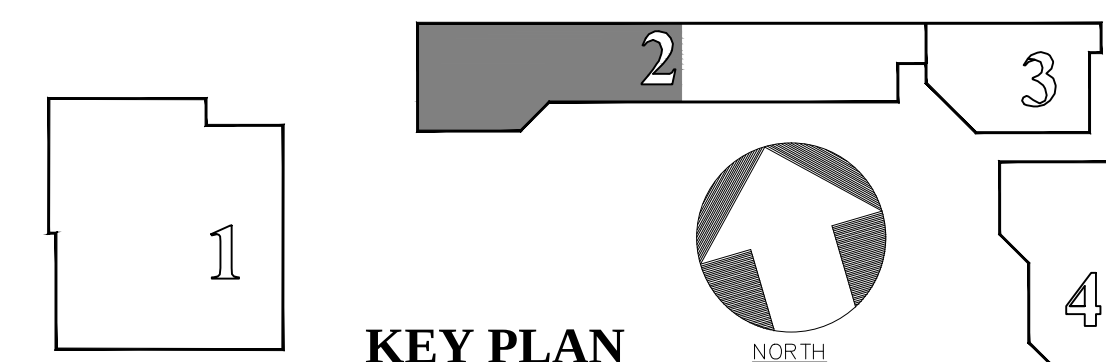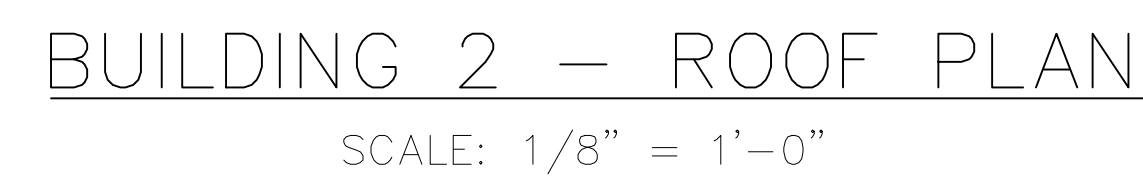

BUILDING 2 ROOFPLAN


AB-8

- ☒ ROOF OUTLINE INCLUDING VALLEYS
- ☒ RIDGES
- ☒ HIPS
- ☒ SLOPE DIRECTION (SHOW WITH ARROWS)
- ☒ AND GRADE (%)
- ☒ DRAINAGE (ROOF DRAIN / OVERFLOW DRAINS)
- ☒ PARAPET WALLS
- ☒ SKYLIGHTS
- ☒ CHIMNEYS
- ☒ RTU'S AND ANY EQUIPMENT
- ☒ LOCATIONS OF ANY PLUMBING RUNNING ALONG THE ROOF (E.G. GAS)
- ☒ BUILDING LINE
- ☒ PROVIDE ELEVATION POINTS FOR ROOF SURFACE, INCLUDING TOP OF PARAPET, VALLEYS, DRAINS AND RIDGES.

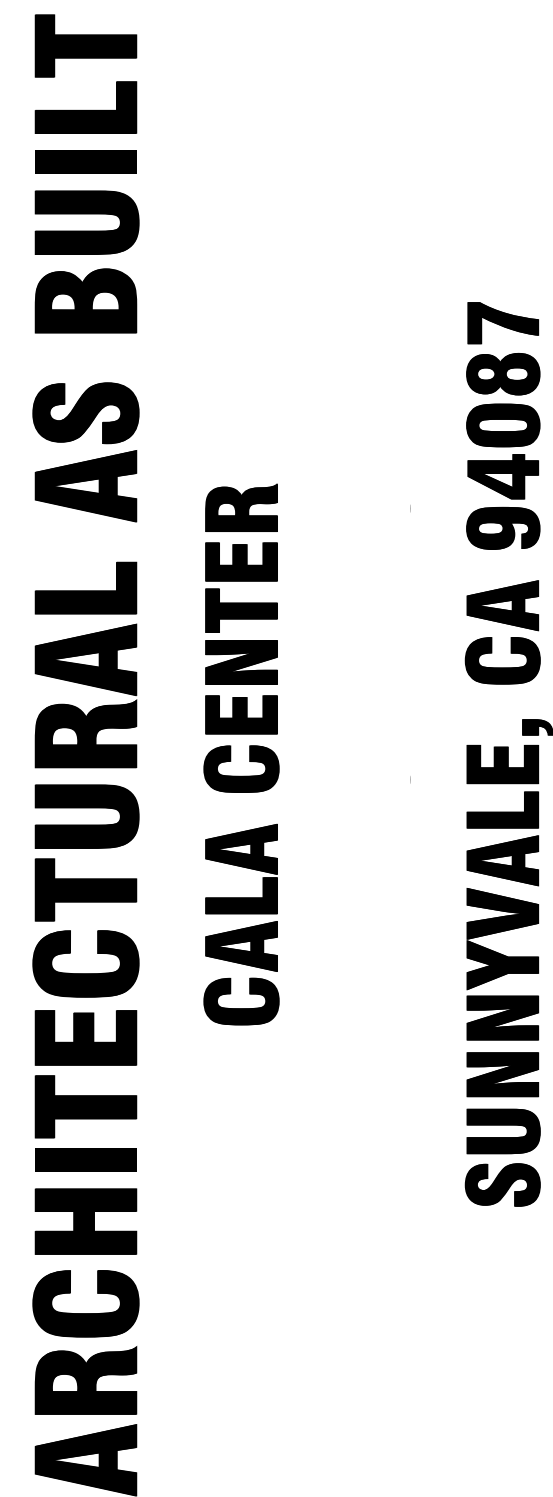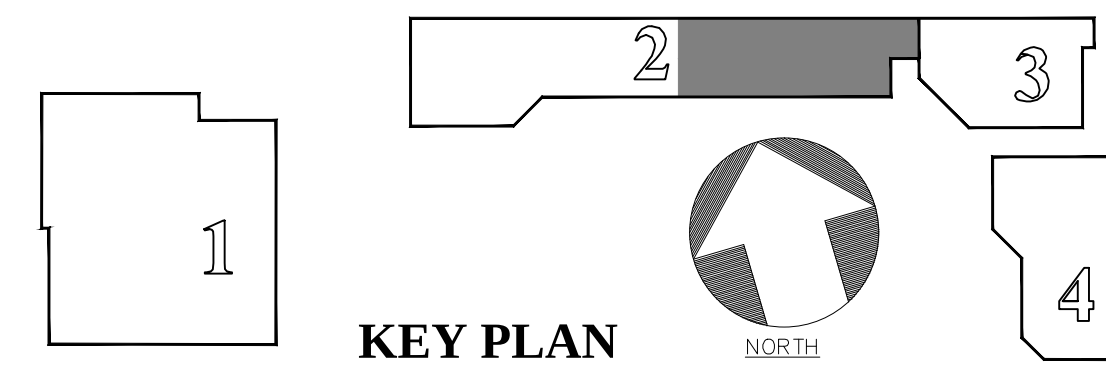


BUILDING 2 ROOFPLAN

AB-9

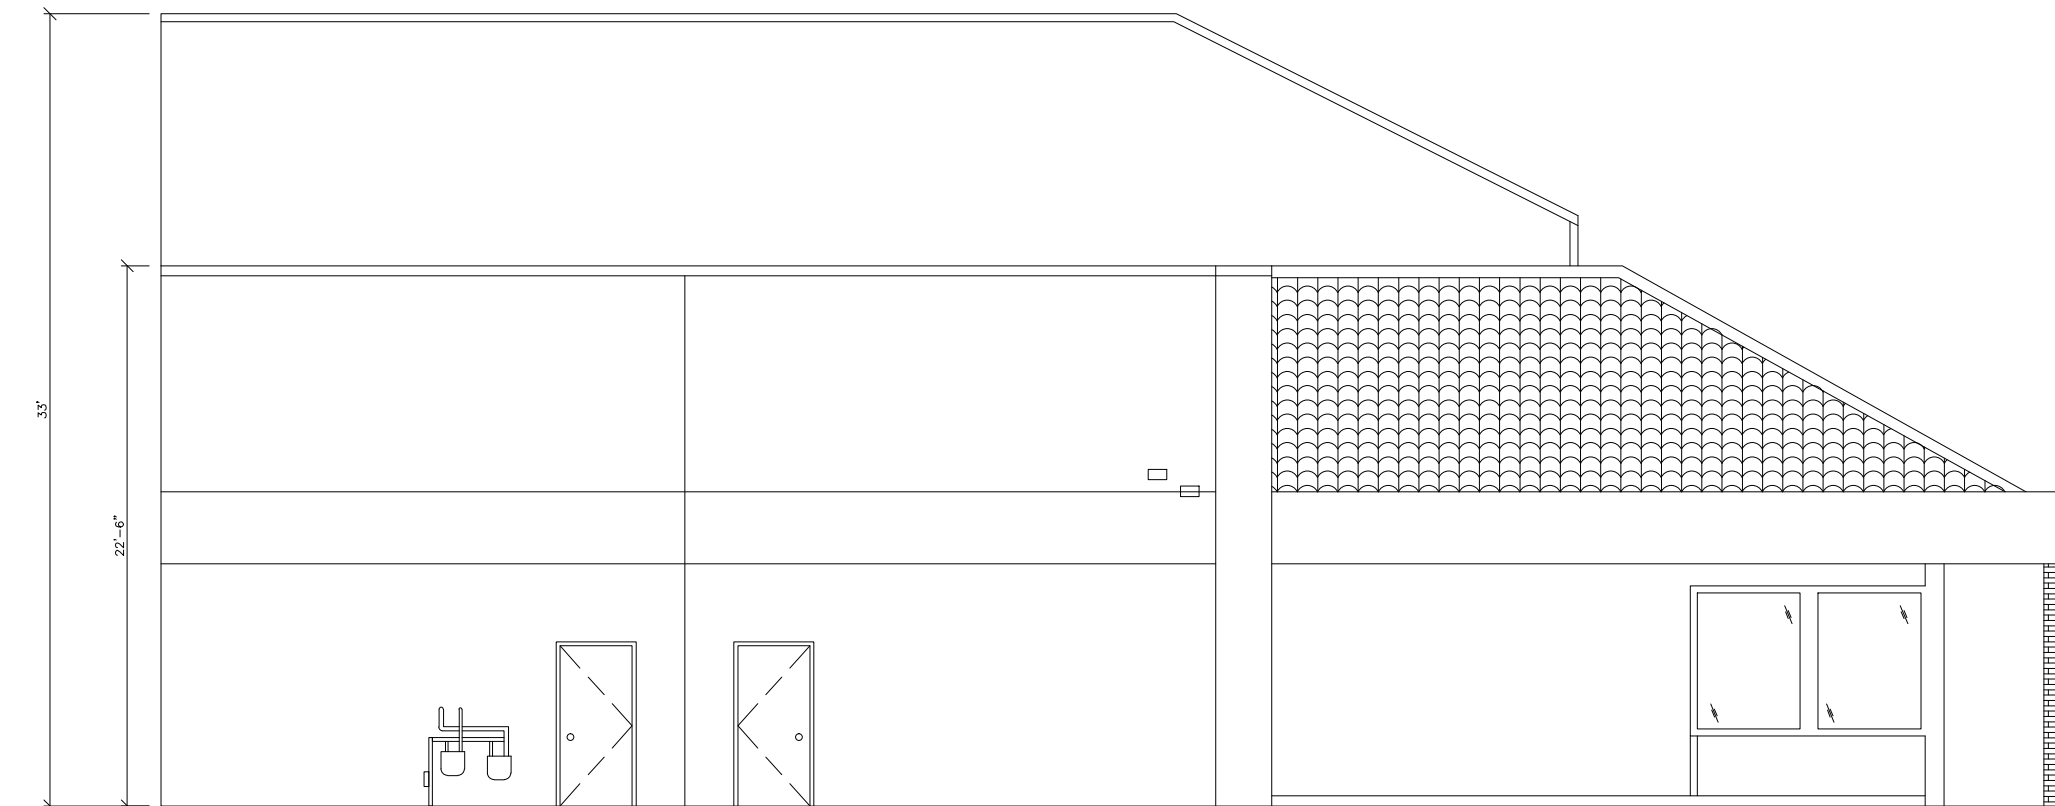

③ BUILDING 2 – WEST ELEVATION

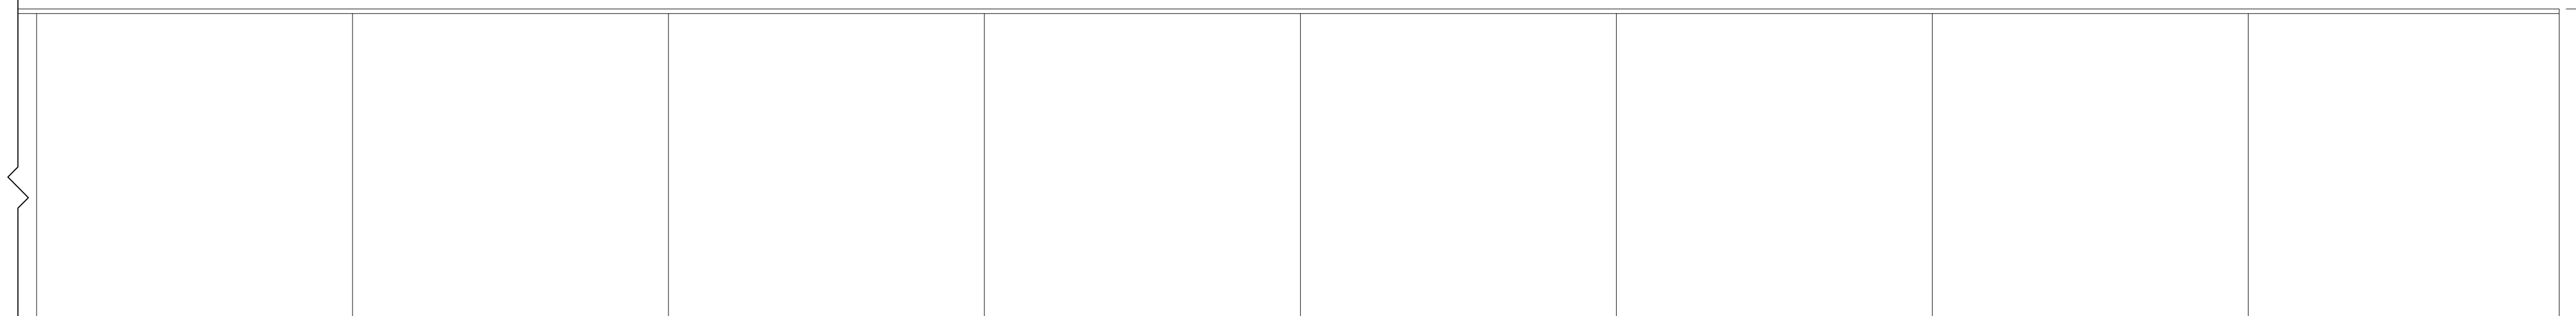

② BUILDING 2 – NORTH ELEVATION

① BUILDING 2 — NORTH ELEVATION
SCALE: $1/8" = 1'-0"$

MATCHLINE 1

MATCHLINE 2


MATCHLINE 1

[illegible]

BUILDING 2 ELEVATIONS



HL	PROJECT MANAGER
HL	PROJECT DIRECTOR
	PROJECT NUMBER
1/8"=1'-0"	SCALE
MM	DRAWN BY
	SHEET NUMBER

AB-10

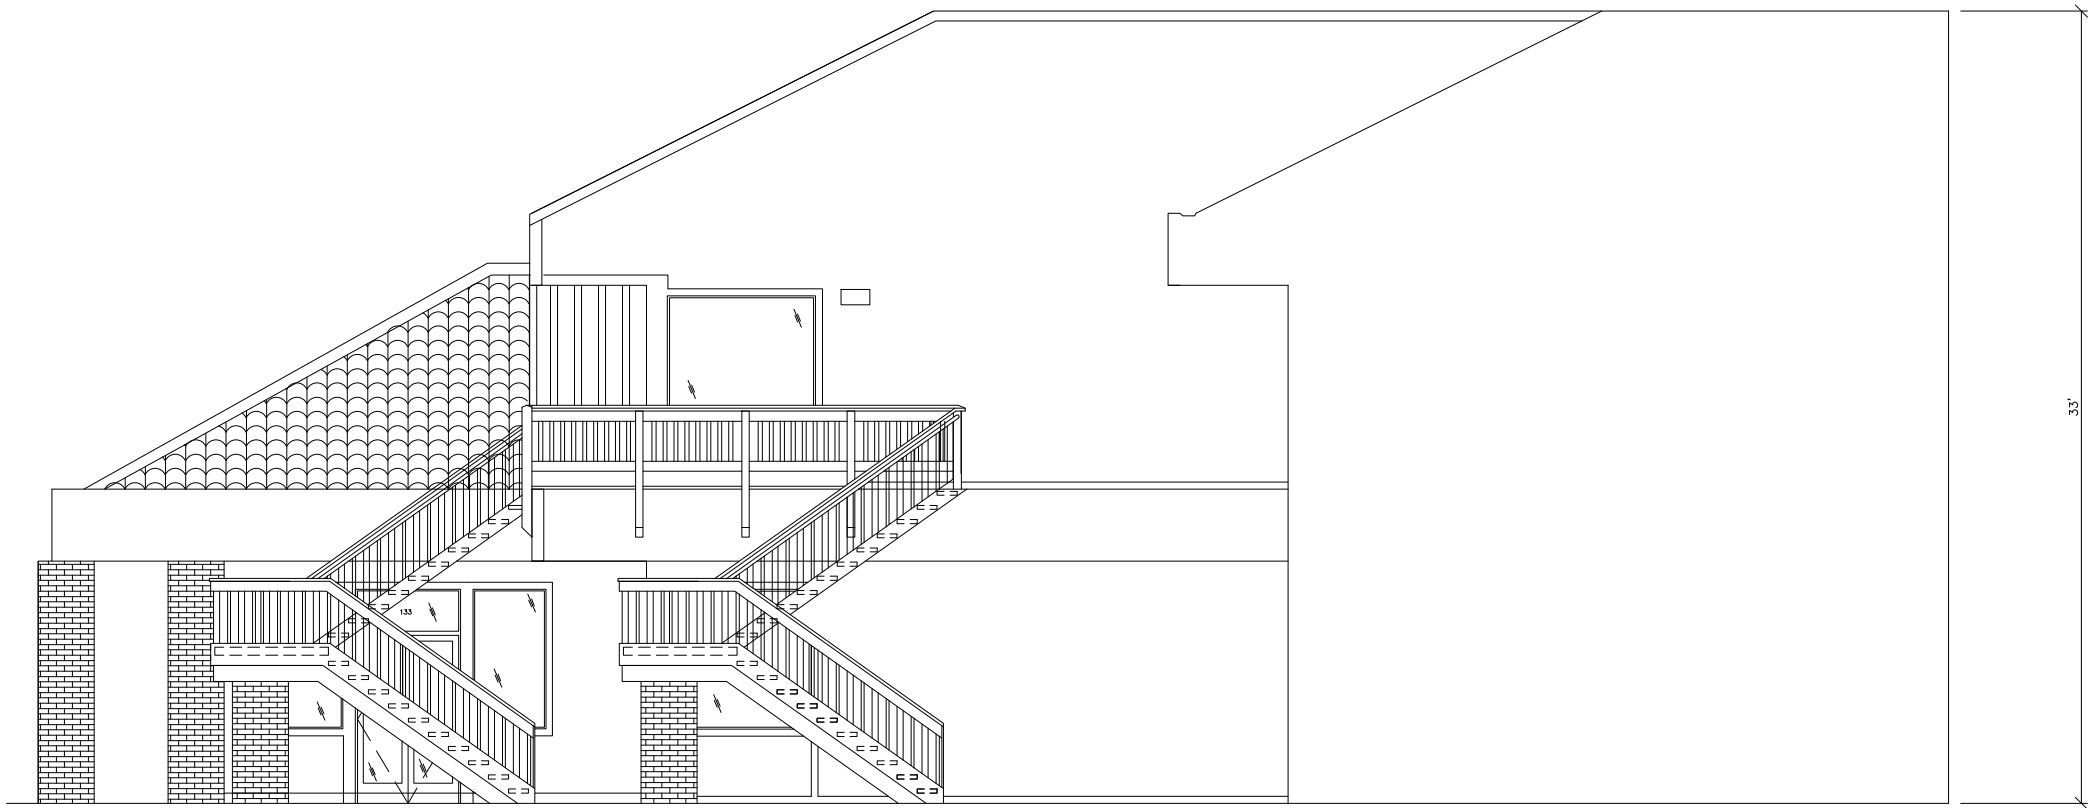


⑥ BUILDING 2 – EAST ELEVATION

 SCALE: 1/8" = 1'-0"

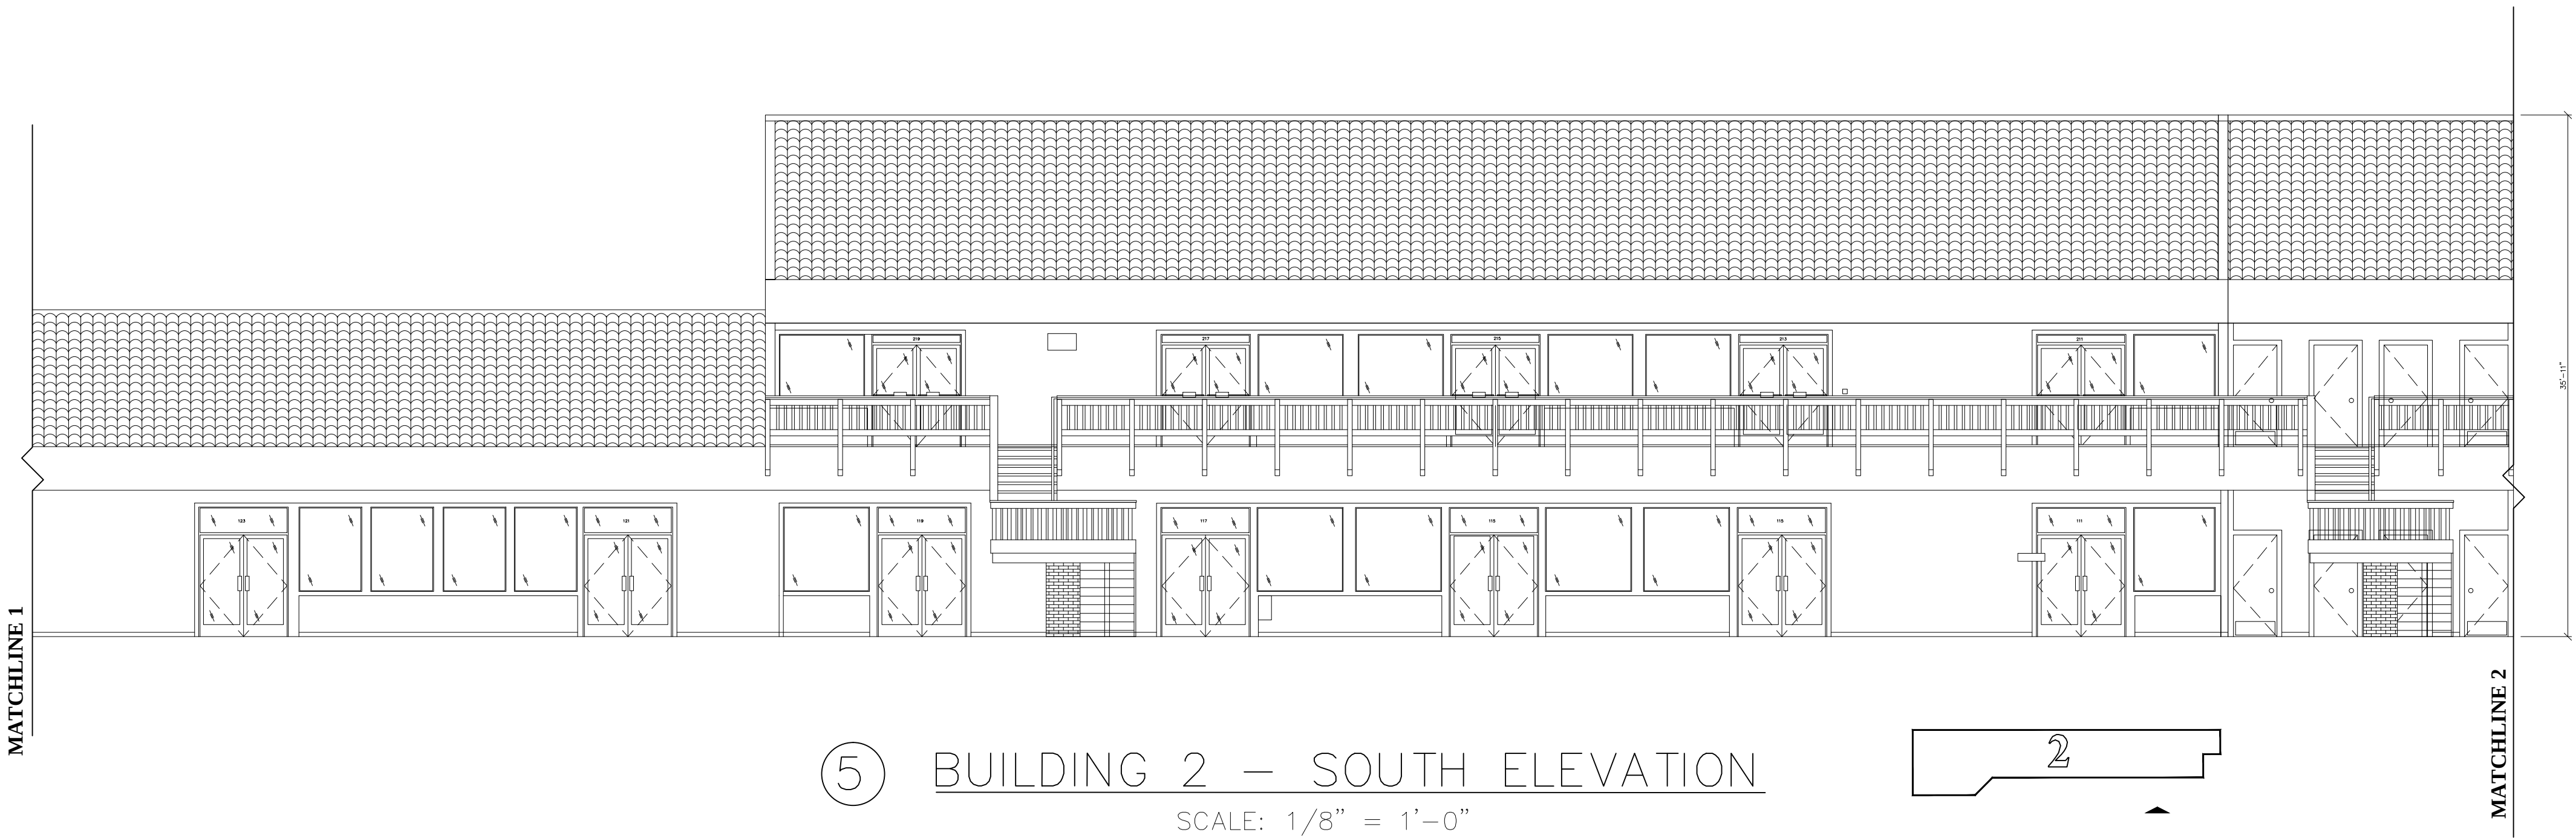


⑤ BUILDING 2 – SOUTH ELEVATION

 SCALE: 1/8" = 1'-0"



④ BUILDING 2 – SOUTH ELEVATION

 SCALE: 1/8" = 1'-0"



© 2021 AEC CONSULTANTS, INC.

ARCHITECTURAL AS BUILT

CALA CENTER

SUNNYVALE, CA 94087



NO.	REVISION	DATE
1	REVISION	
NO.	ISSUES REVISIONS	DATE
SHEET TITLE		
BUILDING 2 ELEVATIONS		
HL	PROJECT MANAGER	
HL	PROJECT DIRECTOR	
	PROJECT NUMBER	
	SCALE	
MM	DRAWN BY	
	SHEET NUMBER	

BUILDING 2 ELEVATIONS

1/8"=1'-0"

AB-11

- ☒ FLOOR PLANS DIMENSIONED
- ☒ TENANT DEMISING AND TENANT PARTITION WALLS
- ☒ WINDOWS, DOORS WITH (SIZES LABELED),
- ☒ BUILT-INS, COLUMNS,
- ☒ STRUCTURAL ELEMENTS SUCH AS
- ☒ DIAGONAL BRACING ,STAIRS
- ☒ ALL ROOF ACCESS LADDERS
- ☒ LABELING OF ALL ROOMS AND SPACES
- ☒ INDICATE OVERHANGS AND CANOPIES ABOVE AND NOTE HEIGHTS
- ☒ ALL COLUMNS ON THE OUTSIDE OF THE BUILDING
- ☒ SHOW MAJOR MEP ITEMS ON FLOORS AND WALLS
IE. BUILT-INS, TOILETS, SINKS, FLOOR DRAINS,
WATER HEATERS, AHU UNITS, (INSIDE THE
ENVELOPE).
- ☒ SHOW LOCATION OF ELECTRICAL PANELS (TAKE
- ☒ PICS OF PANEL AND DIRECTORY)
- ☒ FIRE SPRINKLER RISERS LOCATIONS AND MAIN PIPE
- ☒ DIAMETER SIZE (TAKE PICS OF RISER)
- ☒ INTERIOR HEIGHTS MEASURED TO BOTTOM OF
- ☒ STRUCTURE/TRUSS ONLY WHEN VISIBLE.

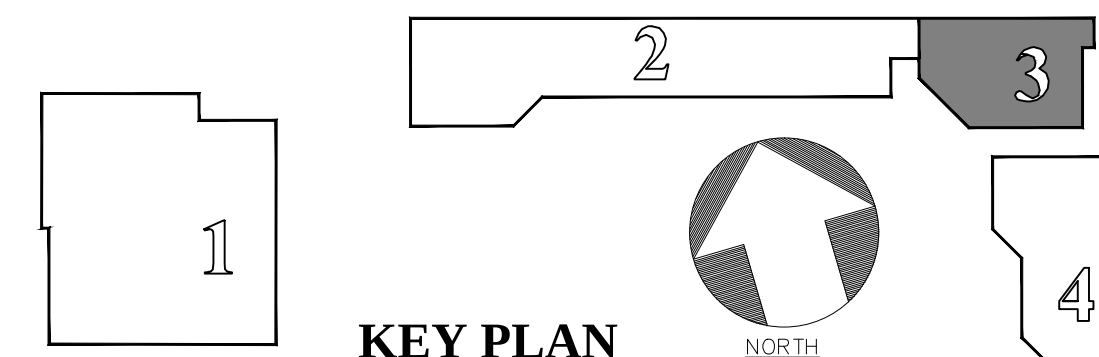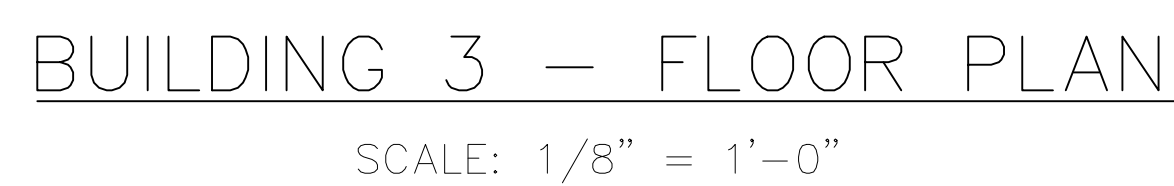


ARCHITECTURAL AS BUILT
CALA CENTER
SUNNYVALE, CA 94087

AB-12


SCOPE OF WORK: ROOF PLAN

- ✓ ROOF OUTLINE INCLUDING VALLEYS
- ✓ RIDGES
- ✓ HIPS
- ✓ SLOPE DIRECTION (SHOW WITH ARROWS
- ✓ AND GRADE %)
- ✓ DRAINAGE (ROOF DRAIN / OVERFLOW
- ✓ DRAINS)
- ✓ PARAPET WALLS
- ✓ SKYLIGHTS
- ✓ CHIMNEYS
- ✓ RTU'S AND ANY EQUIPMENT
- ✓ LOCATIONS OF ANY PLUMBING RUNNING
- ✓ ALONG THE ROOF (E.G. GAS)
- ✓ BUILDING LINE
- ✓ PROVIDE ELEVATION POINTS FOR ROOF
- ✓ SURFACE, INCLUDING TOP OF PARAPET,
- ✓ VALLEYS, DRAINS AND RIDGES.

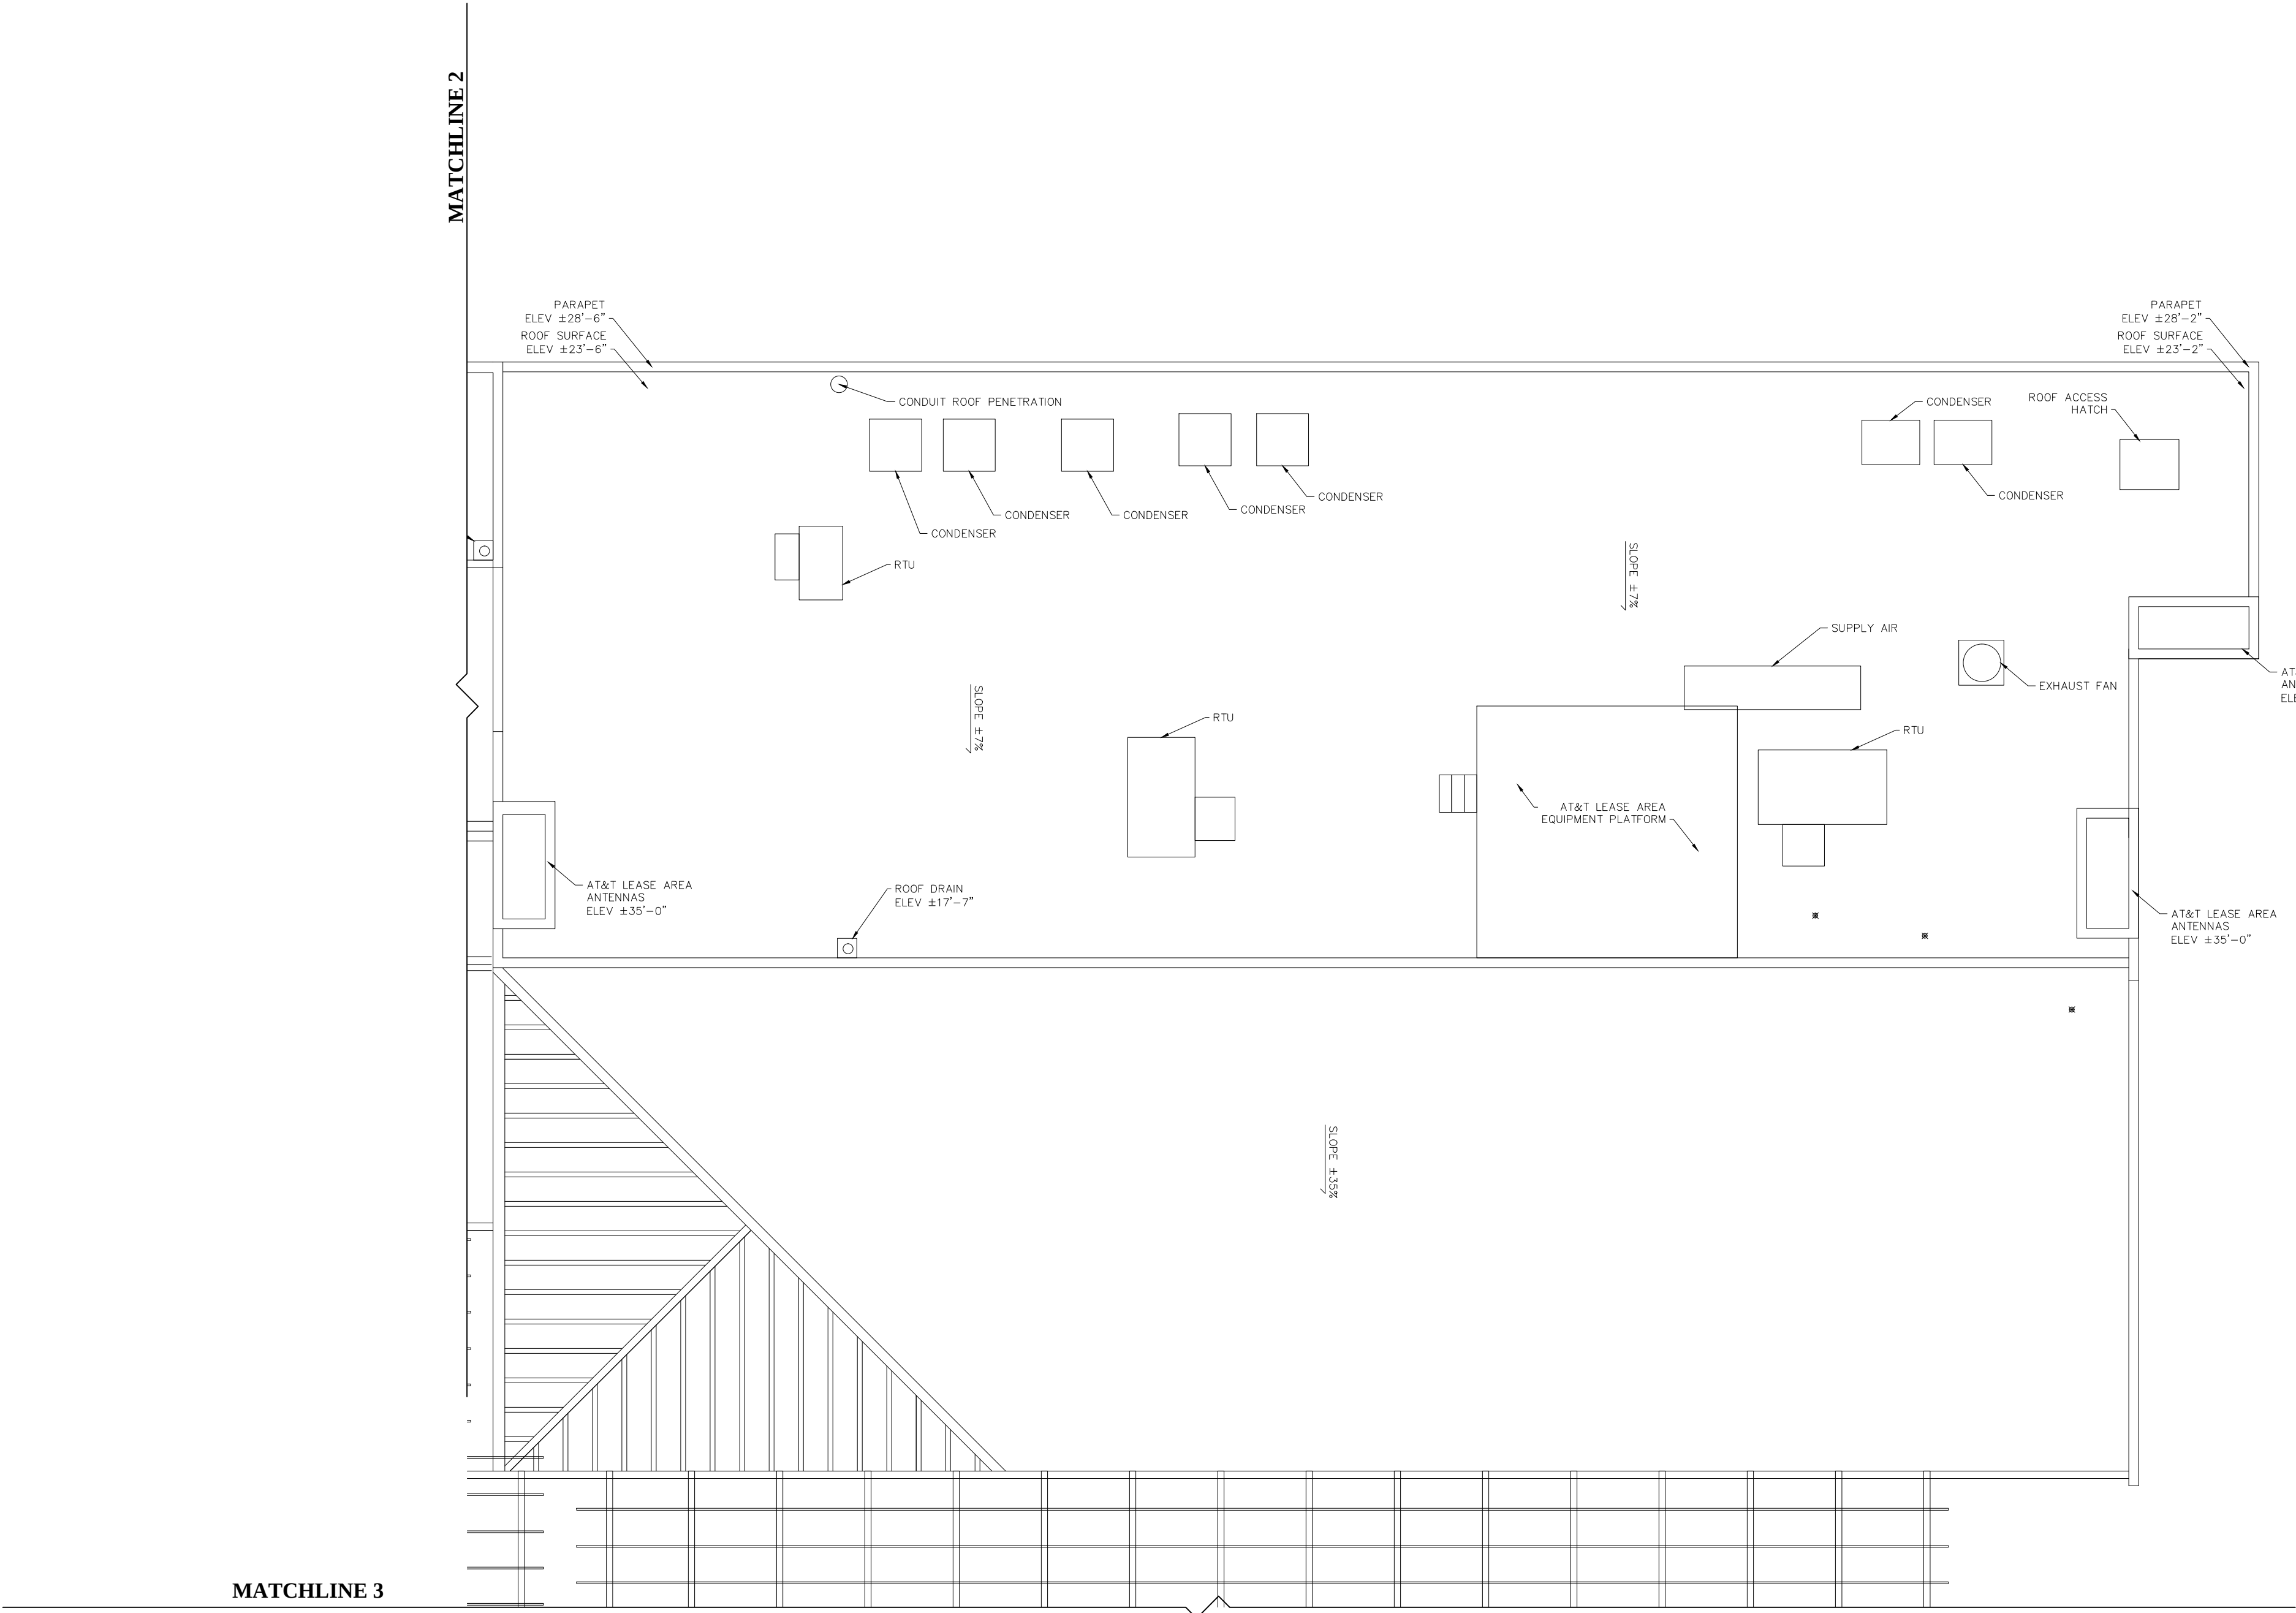

BUILDING 3 — ROOF PLAN

SCALE: 1/8" = 1'-0"

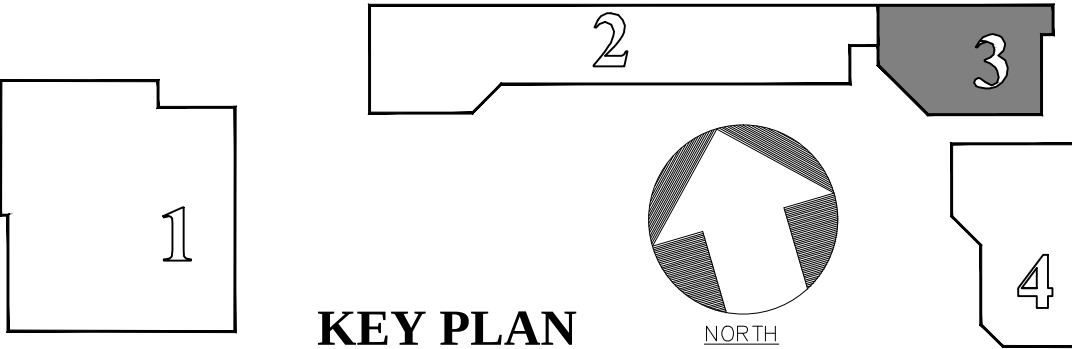


AS BUILT PROFESSIONALS
www.asbuiltprofessionals.com
A DIVISION OF:
AEC CONSULTANTS INC
844.272.8458
844 ASBUILT
© 2021 AEC CONSULTANTS INC

ARCHITECTURAL AS BUILT
CALA CENTER
SUNNYVALE, CA 94087


NO.	REVISION	DATE
1	REVISION	
	ISSUES REVISIONS	

HL	PROJECT MANAGER
HL	PROJECT DIRECTOR
	PROJECT NUMBER
1/8"=1'-0"	SCALE
MM	DRAWN BY
	SHEET NUMBER


AB-13

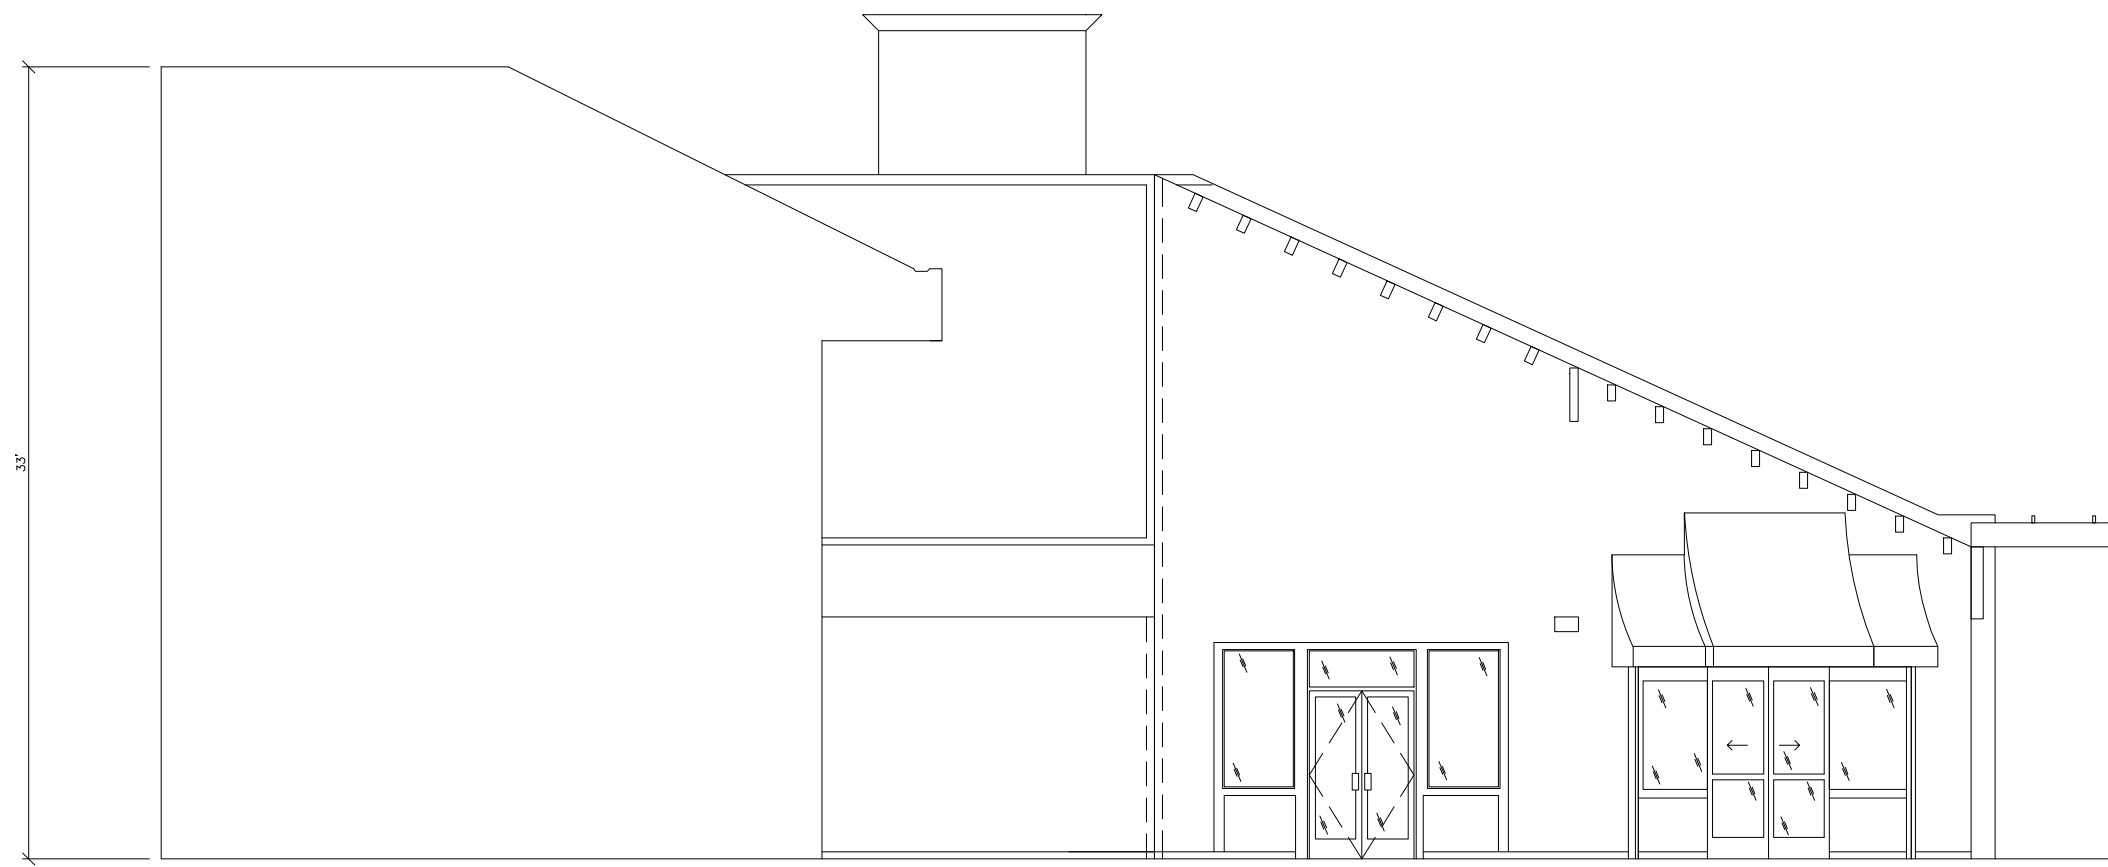


④ BUILDING 3 — EAST ELEVATION
SCALE: 1/8" = 1'-0"

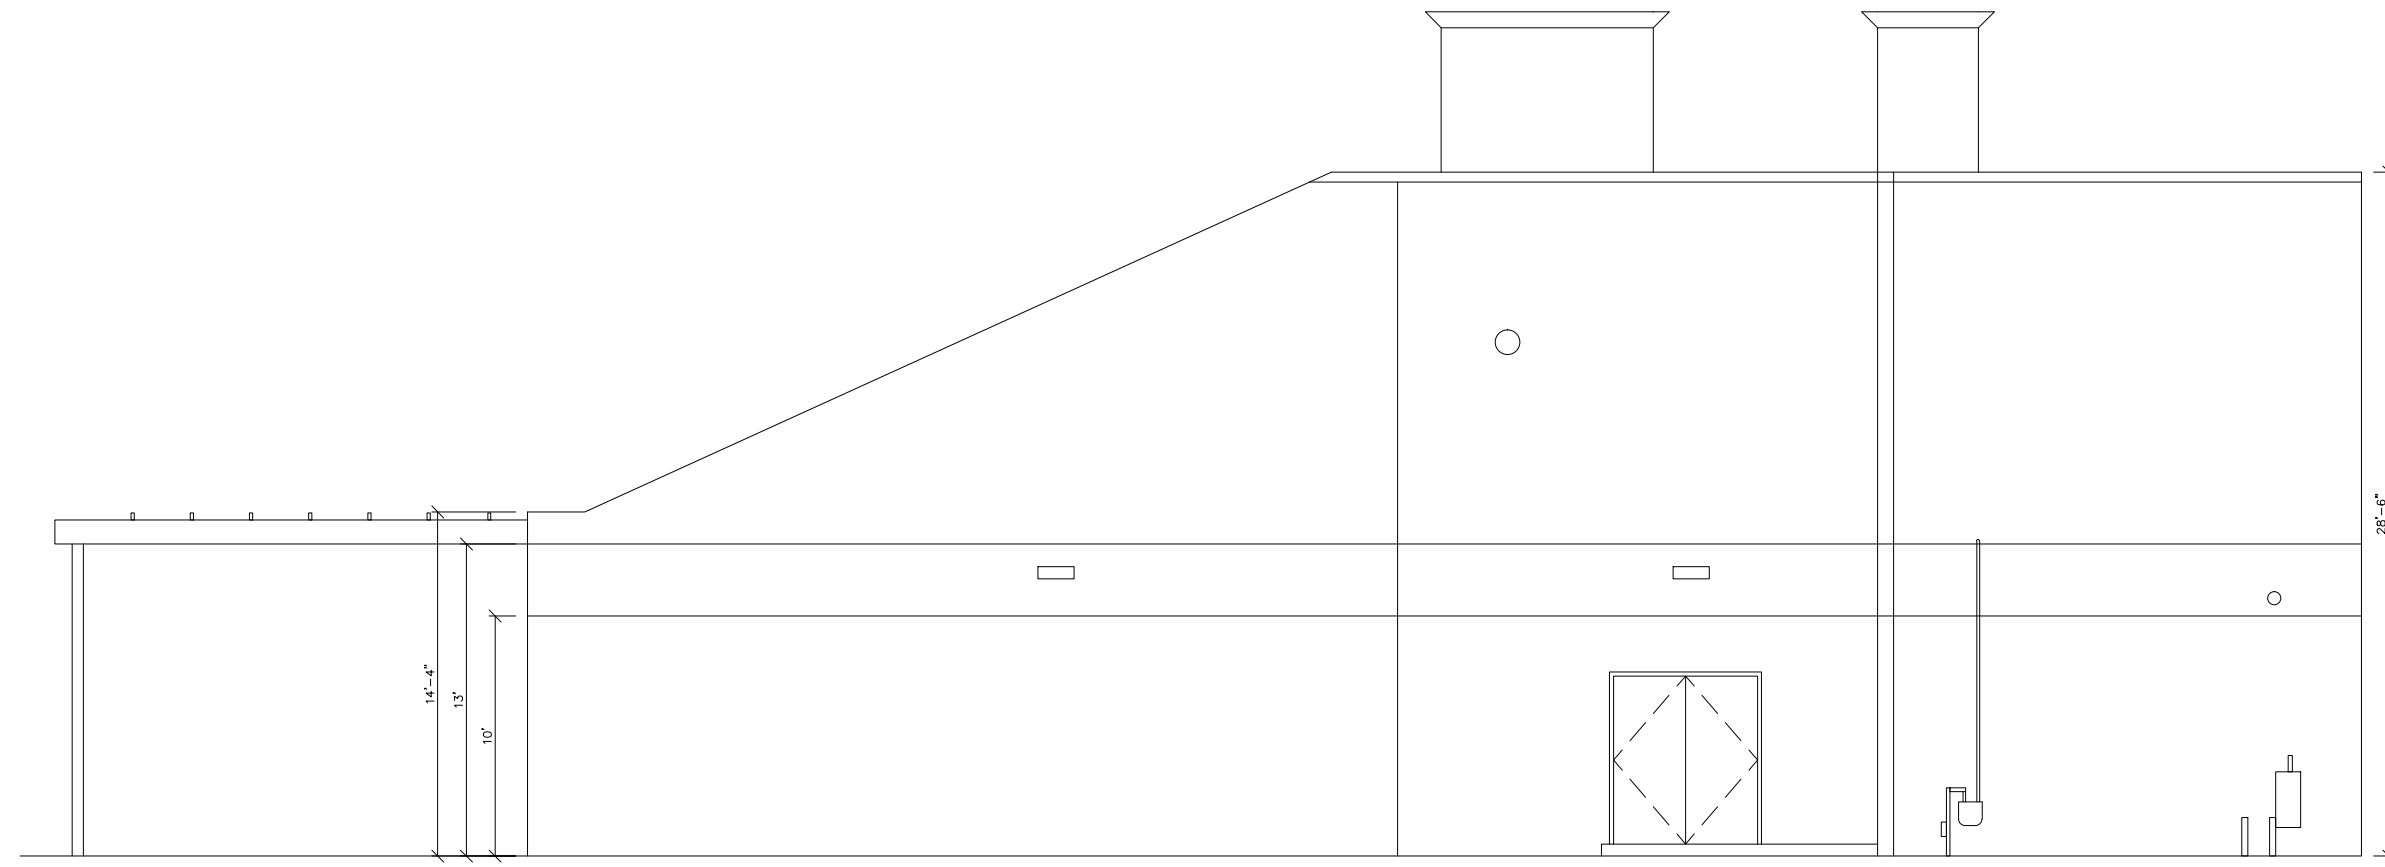


⑤ BUILDING 3 — EAST ELEVATION
SCALE: 1/8" = 1'-0"

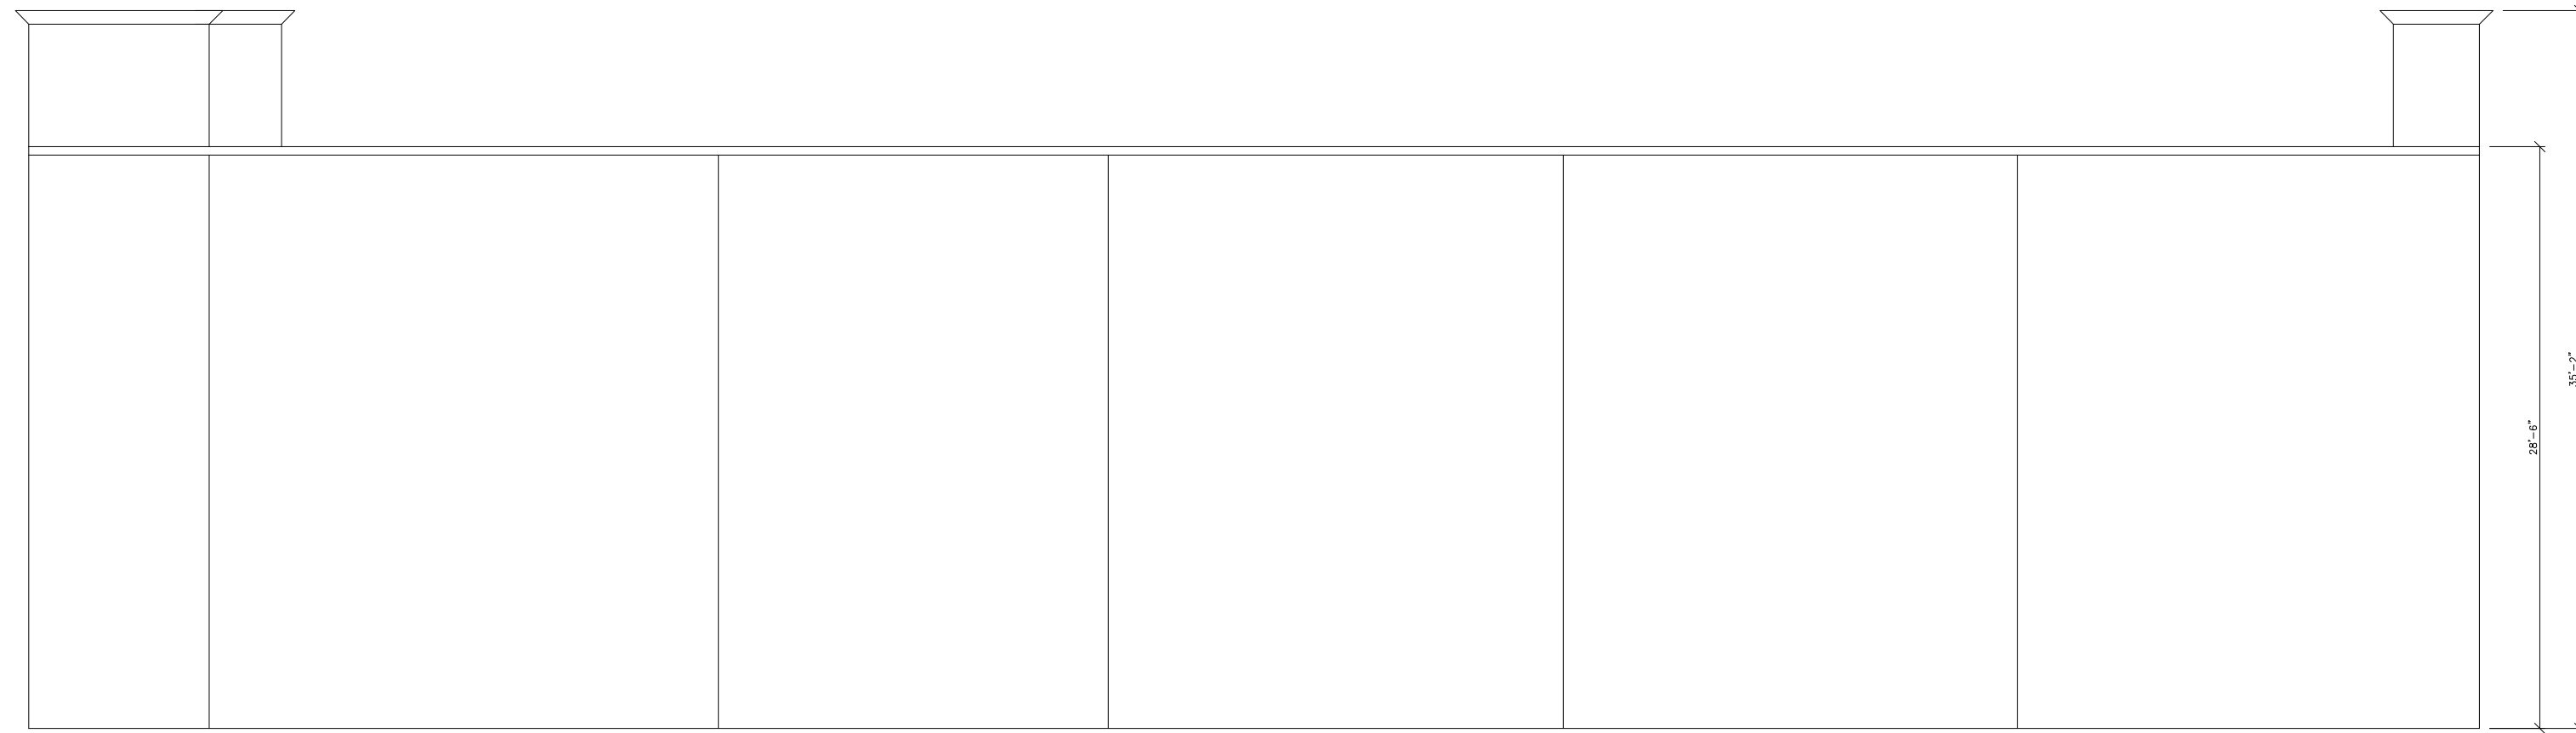

③ BUILDING 3 — NORTH ELEVATION
SCALE: 1/8" = 1'-0"

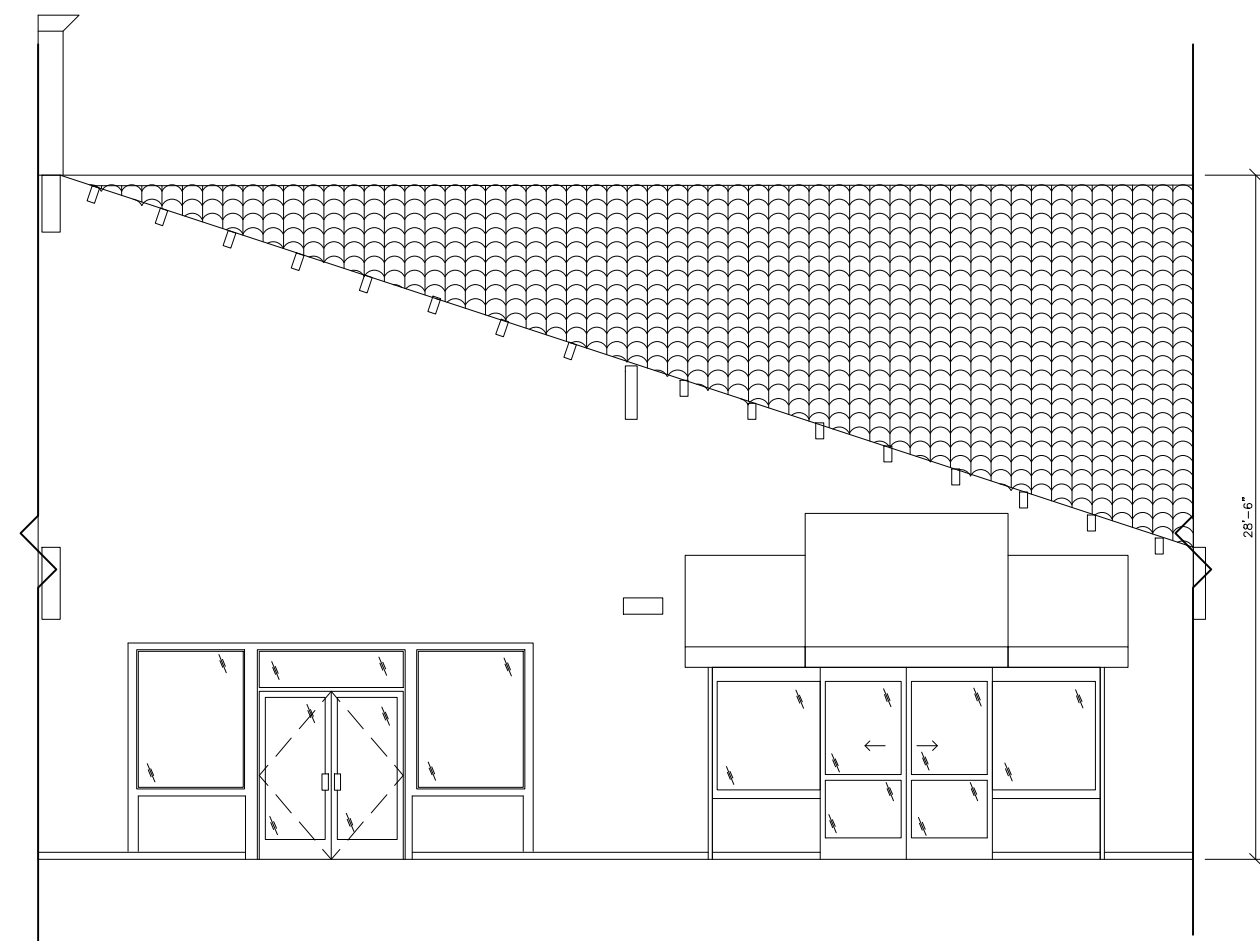

② BUILDING 3 — SOUTHEAST ELEV.
SCALE: 1/8" = 1'-0"

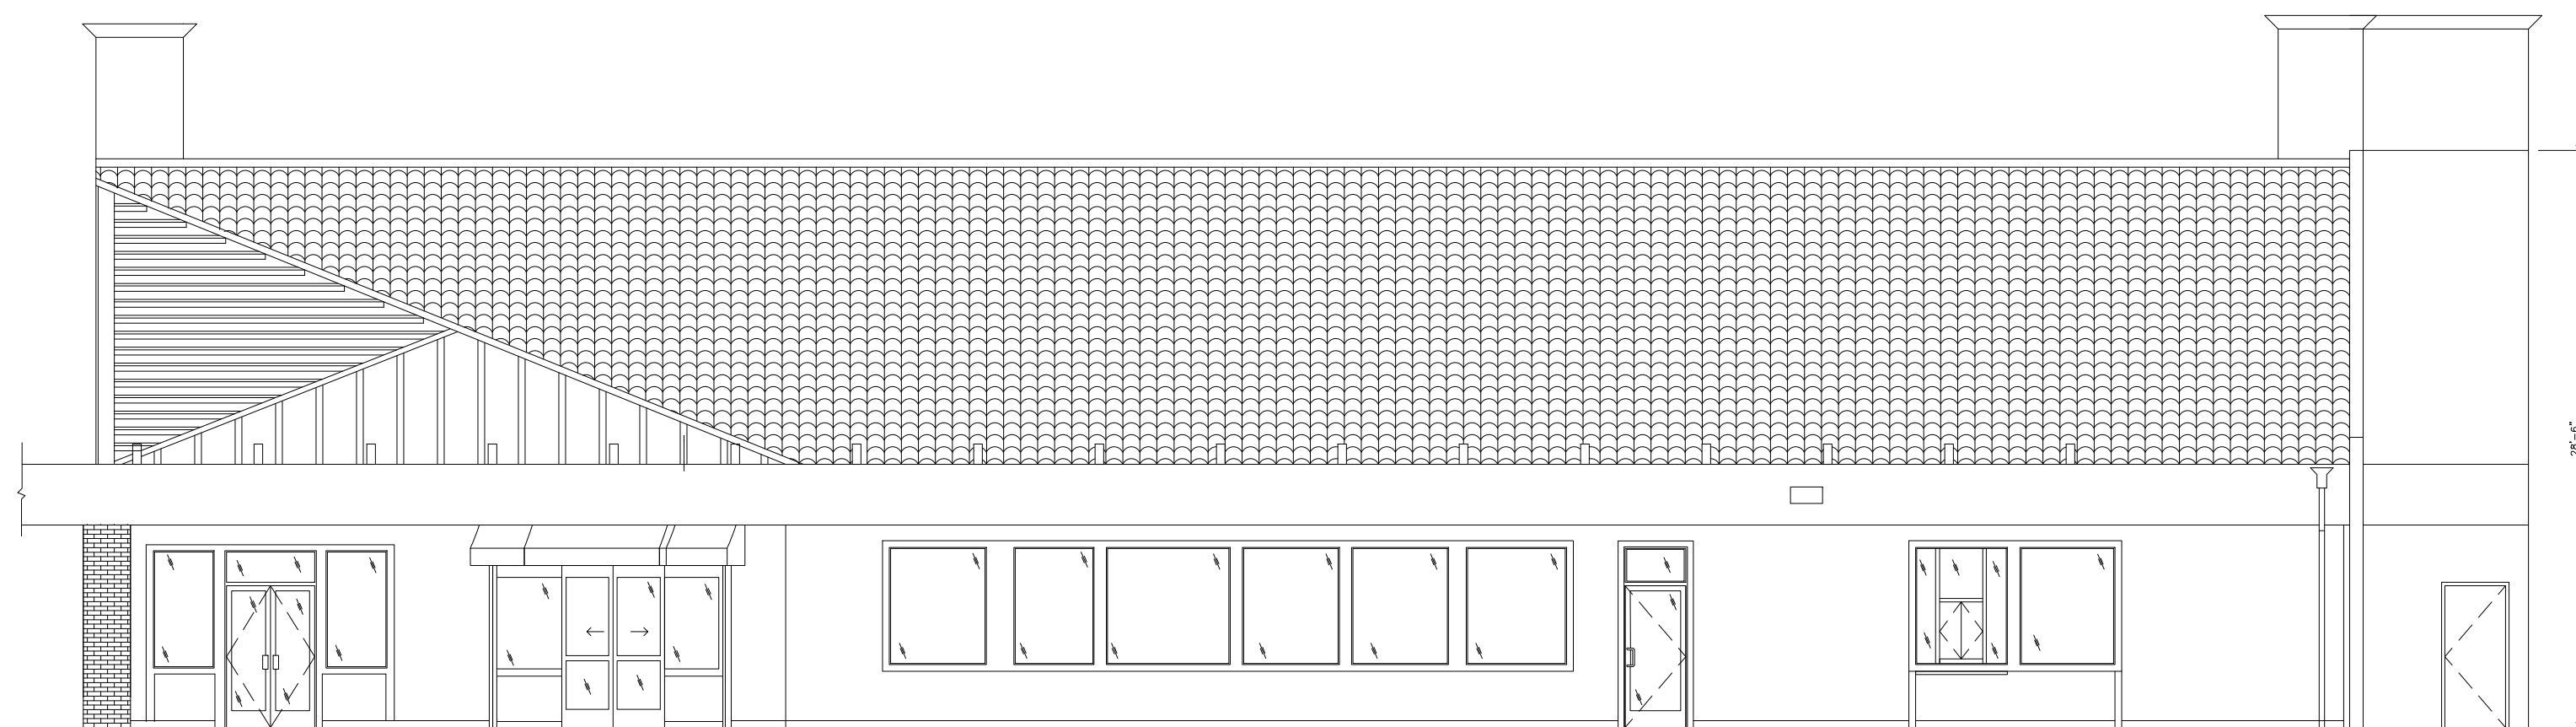

① BUILDING 3 — SOUTH ELEVATION
SCALE: 1/8" = 1'-0"

AS BUILT

PROFESSIONALS

www.asbuiltprofessionals.com

A DIVISION OF:

AEC

CONSULTANTS INC

844.272.8458

844 AS BUILT

© 2021 AEC CONSULTANTS INC

ARCHITECTURAL AS BUILT
CALA CENTER
SUNNYVALE, CA 94087



1	REVISION	
NO.	ISSUES REVISIONS	DATE
SHEET TITLE		
BUILDING 3 ELEVATIONS		
HL	PROJECT MANAGER	
HL	PROJECT DIRECTOR	
	PROJECT NUMBER	
1/8"=1'-0"	SCALE	
MM	DRAWN BY	
	SHEET NUMBER	

- ☒ FLOOR PLANS DIMENSIONED
- ☒ TENANT DEMISING AND TENANT PARTITION WALLS
- ☒ WINDOWS, DOORS WITH (SIZES LABELED),
- ☒ BUILT-INS, COLUMNS,
- ☒ STRUCTURAL ELEMENTS SUCH AS
- ☒ DIAGONAL BRACING ,STAIRS
- ☒ ALL ROOF ACCESS LADDERS
- ☒ LABELING OF ALL ROOMS AND SPACES
- ☒ INDICATE OVERHANGS AND CANOPIES ABOVE AND NOTE HEIGHTS
- ☒ ALL COLUMNS ON THE OUTSIDE OF THE BUILDING
- ☒ SHOW MAJOR MEP ITEMS ON FLOORS AND WALLS
IE. BUILT-INS, TOILETS, SINKS, FLOOR DRAINS,
WATER HEATERS, AHU UNITS, (INSIDE THE ENVELOPE).
- ☒ SHOW LOCATION OF ELECTRICAL PANELS (TAKE
- ☒ PICS OF PANEL AND DIRECTORY)
- ☒ FIRE SPRINKLER RISERS LOCATIONS AND MAIN PIPE
- ☒ DIAMETER SIZE (TAKE PICS OF RISER)
- ☒ INTERIOR HEIGHTS MEASURED TO BOTTOM OF
- ☒ STRUCTURE/TRUSS ONLY WHEN VISIBLE.



BUILDING 4 – FLOOR PLAN

SCALE: 1/8" = 1'-0"

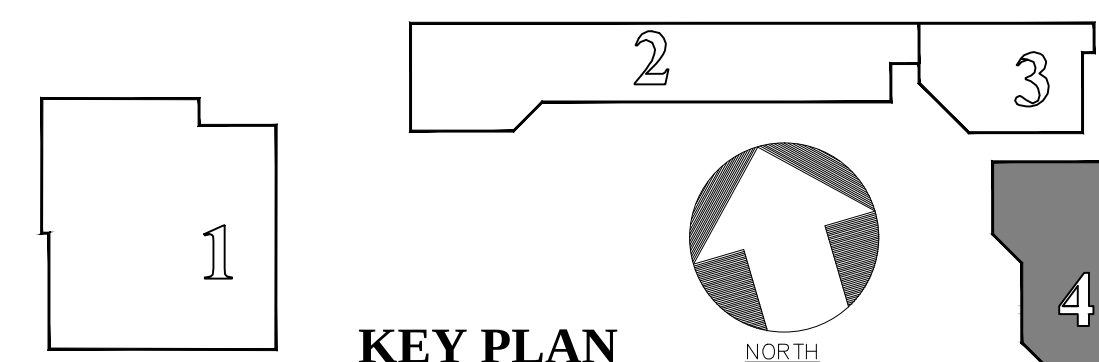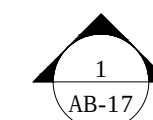

© 2021 AEC CONSULTANTS INC

ARCHITECTURAL AS BUILT

CALA CENTER

SUNNYVALE, CA 94087


1	REVISION		
NO.	ISSUES REVISIONS	DATE	
			SHEET TITLE

BUILDING 4 FLOORPLAN


HL	PROJECT MANAGER
HL	PROJECT DIRECTOR
	PROJECT NUMBER
1/8"=1'-0"	SCALE
MM	DRAWN BY
	SHEET NUMBER

AB-15

- ☒ ROOF OUTLINE INCLUDING VALLEYS
- ☒ RIDGES
- ☒ HIPS
- ☒ SLOPE DIRECTION (SHOW WITH ARROWS)
- ☒ AND GRADE (%)
- ☒ DRAINAGE (ROOF DRAIN / OVERFLOW DRAINS)
- ☒ PARAPET WALLS
- ☒ SKYLIGHTS
- ☒ CHIMNEYS
- ☒ RTU'S AND ANY EQUIPMENT
- ☒ LOCATIONS OF ANY PLUMBING RUNNING ALONG THE ROOF (E.G. GAS)
- ☒ BUILDING LINE
- ☒ PROVIDE ELEVATION POINTS FOR ROOF SURFACE, INCLUDING TOP OF PARAPET, VALLEYS, DRAINS AND RIDGES.

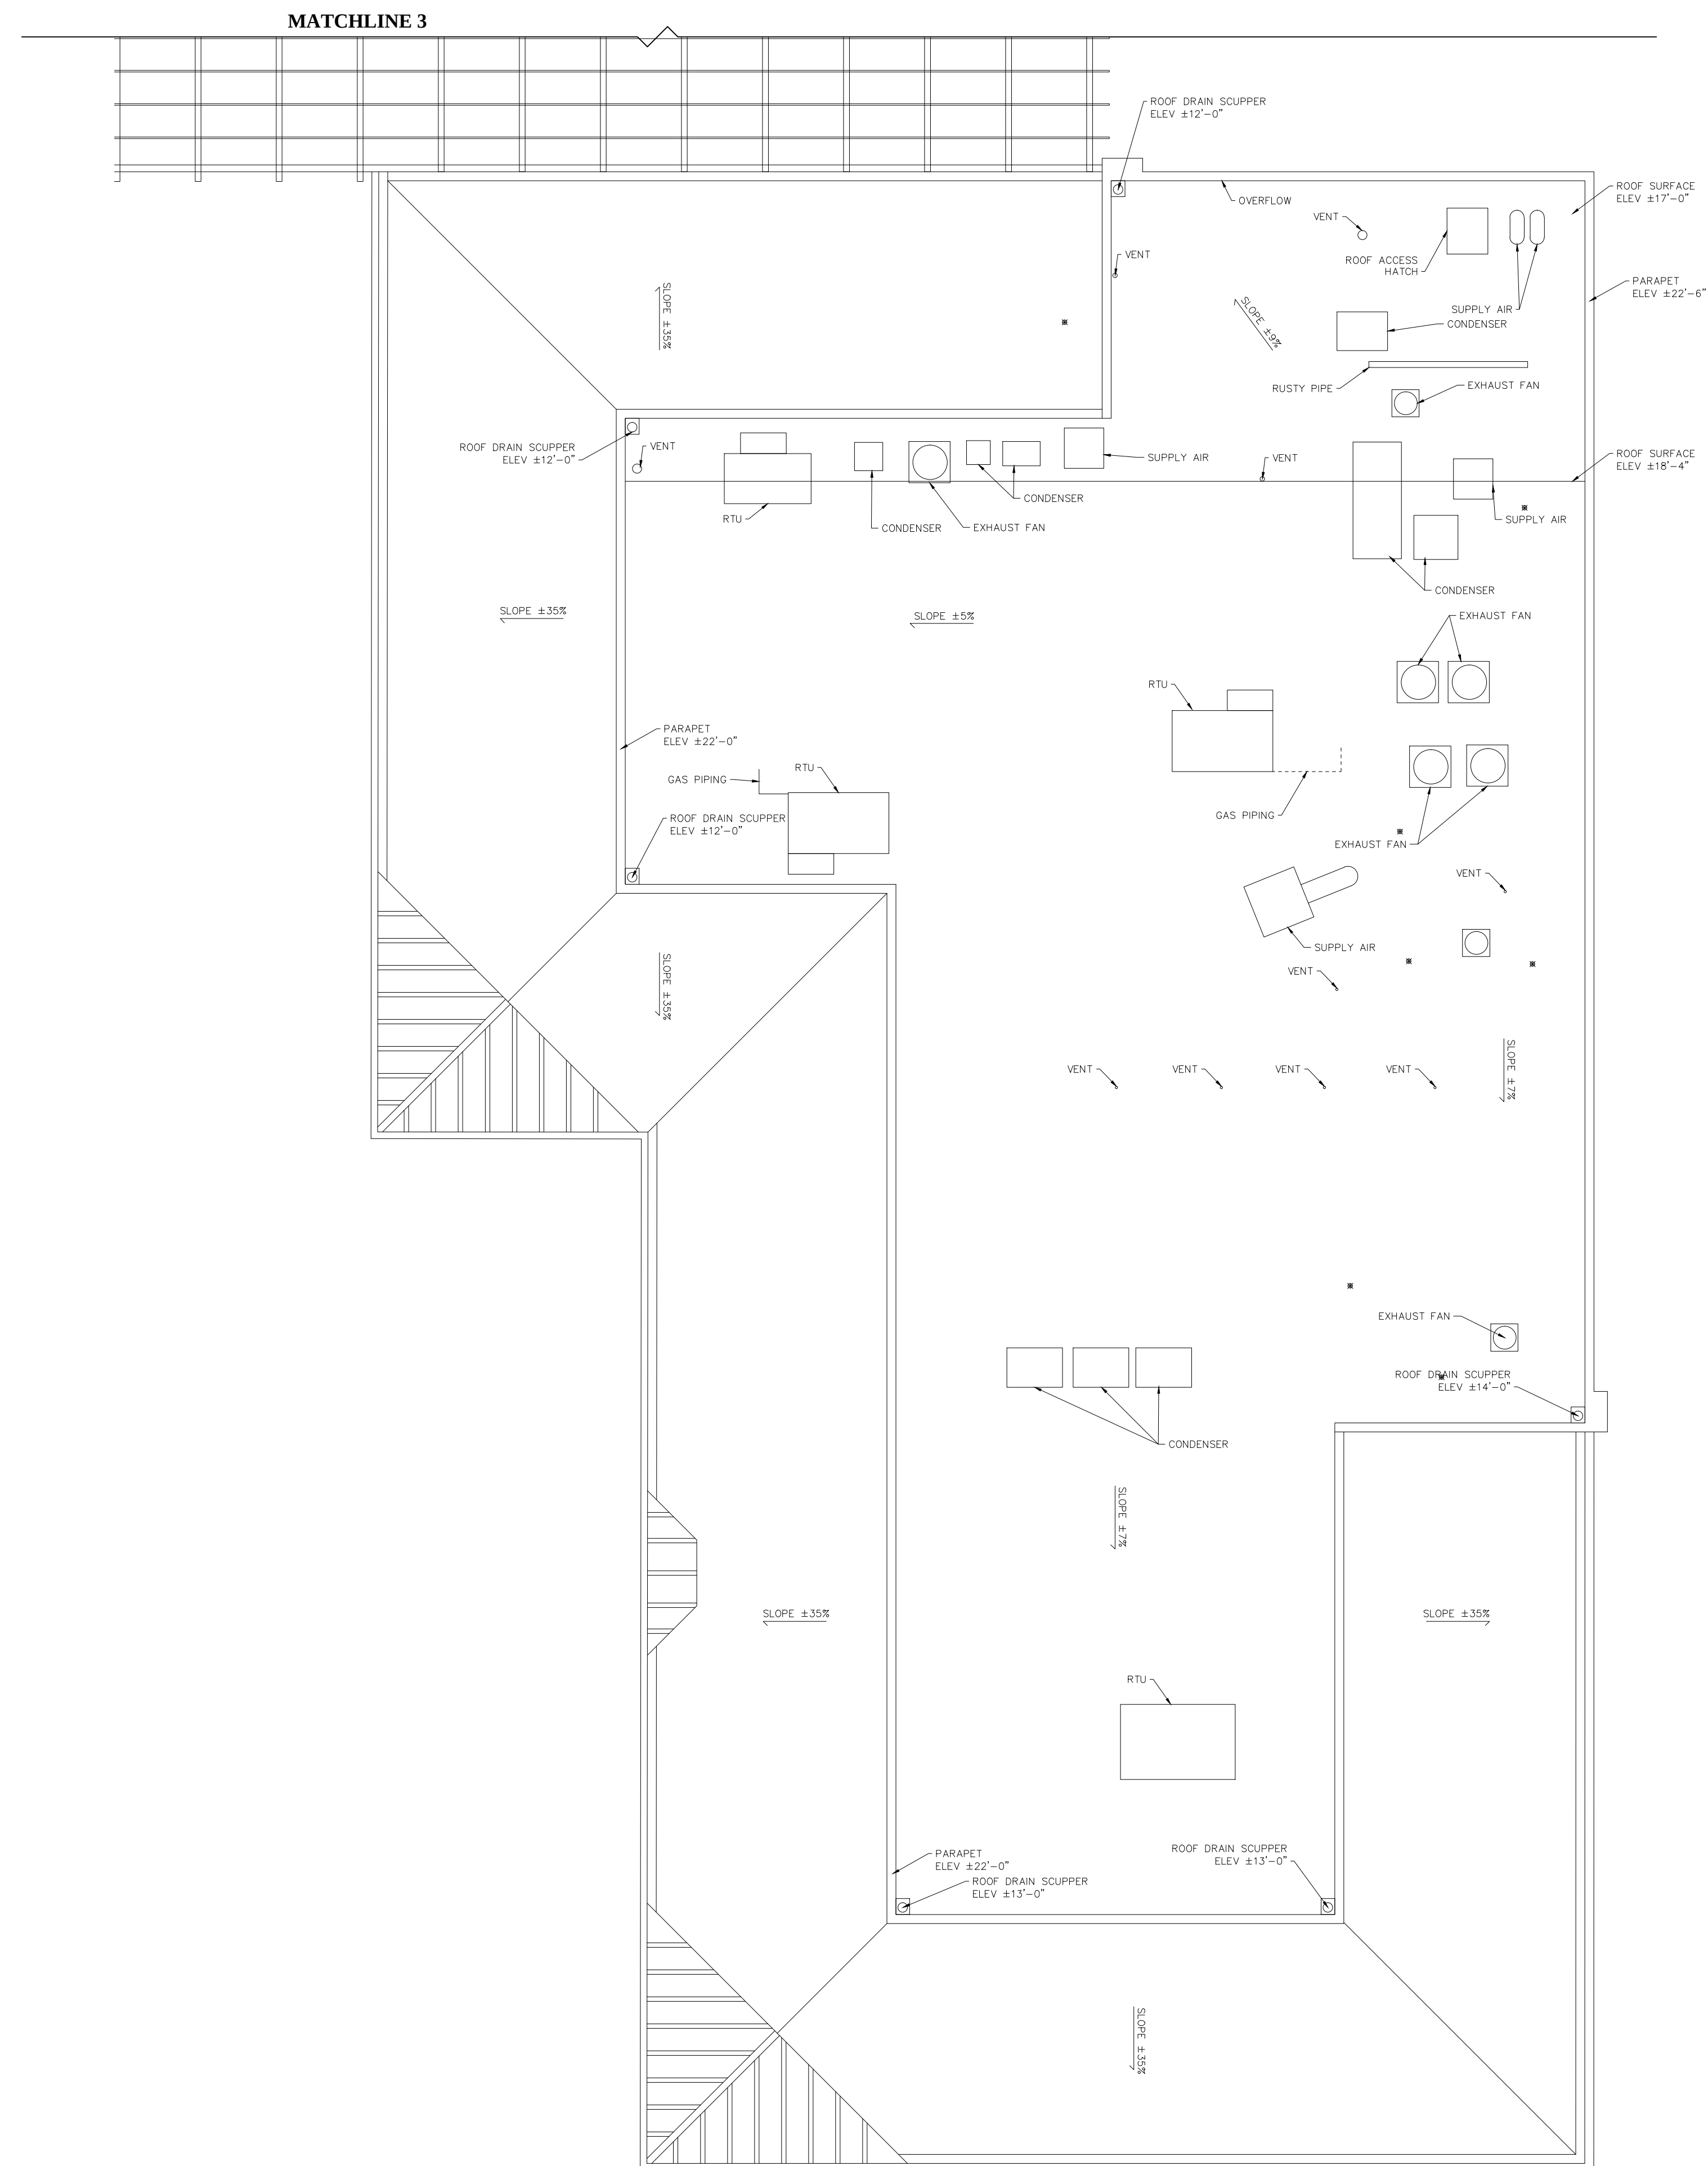

BUILDING 4 – ROOF PLAN
SCALE: 1/8" = 1'-0"

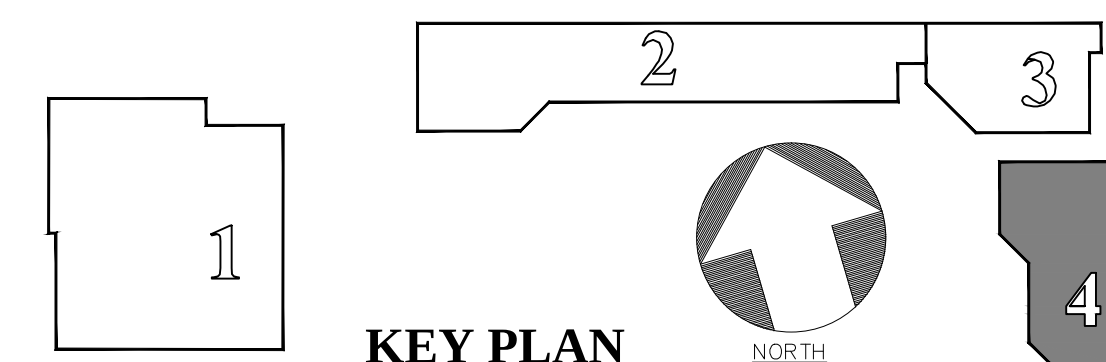


ARCHITECTURAL AS BUILT
CALA CENTER
SUNNYVALE, CA 94087

1	REVISION		
NO.	ISSUES REVISIONS		DATE


BUILDING 4 ROOFPLAN

HL	PROJECT MANAGER
HL	PROJECT DIRECTOR
	PROJECT NUMBER
1/8"=1'-0"	SCALE
MM	DRAWN BY
	SHEET NUMBER


AB-16

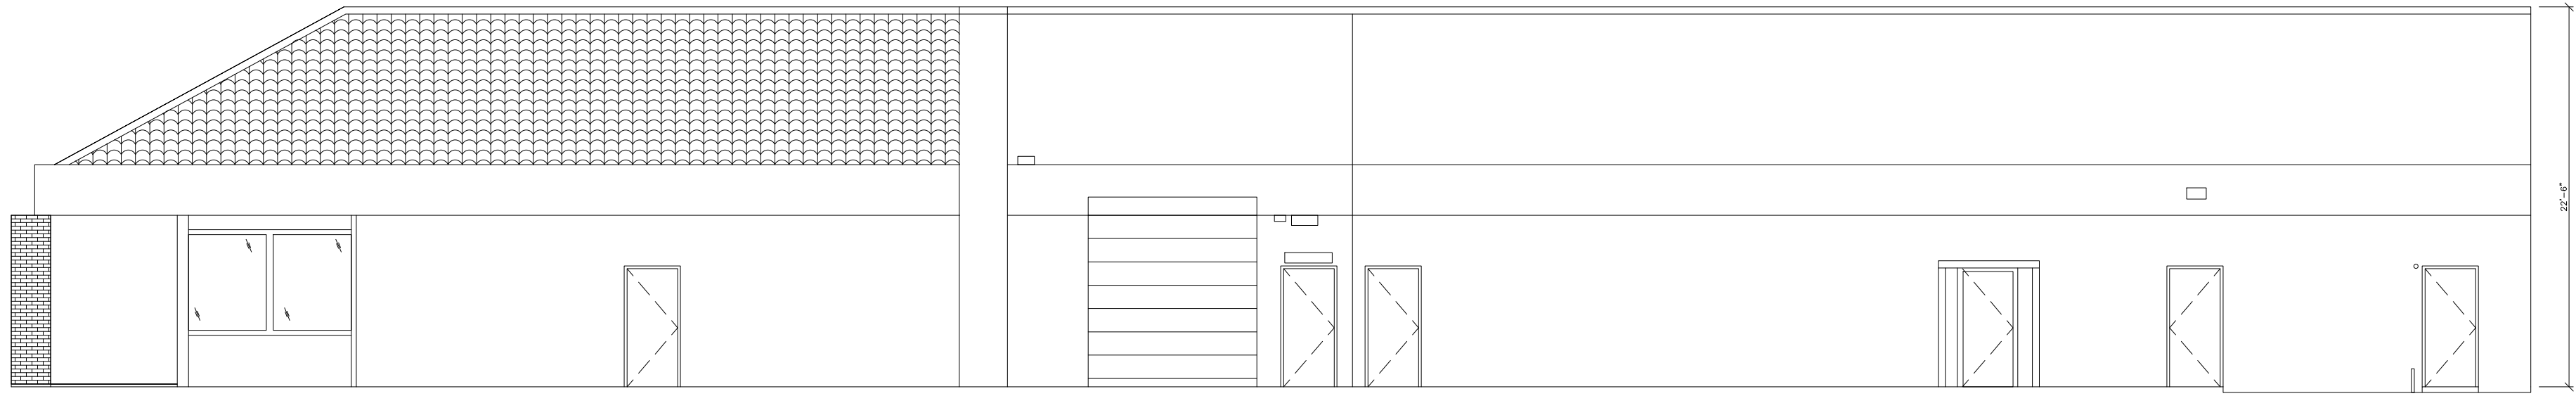


④ BUILDING 4 — EAST ELEVATION
SCALE: 1/8" = 1'-0"

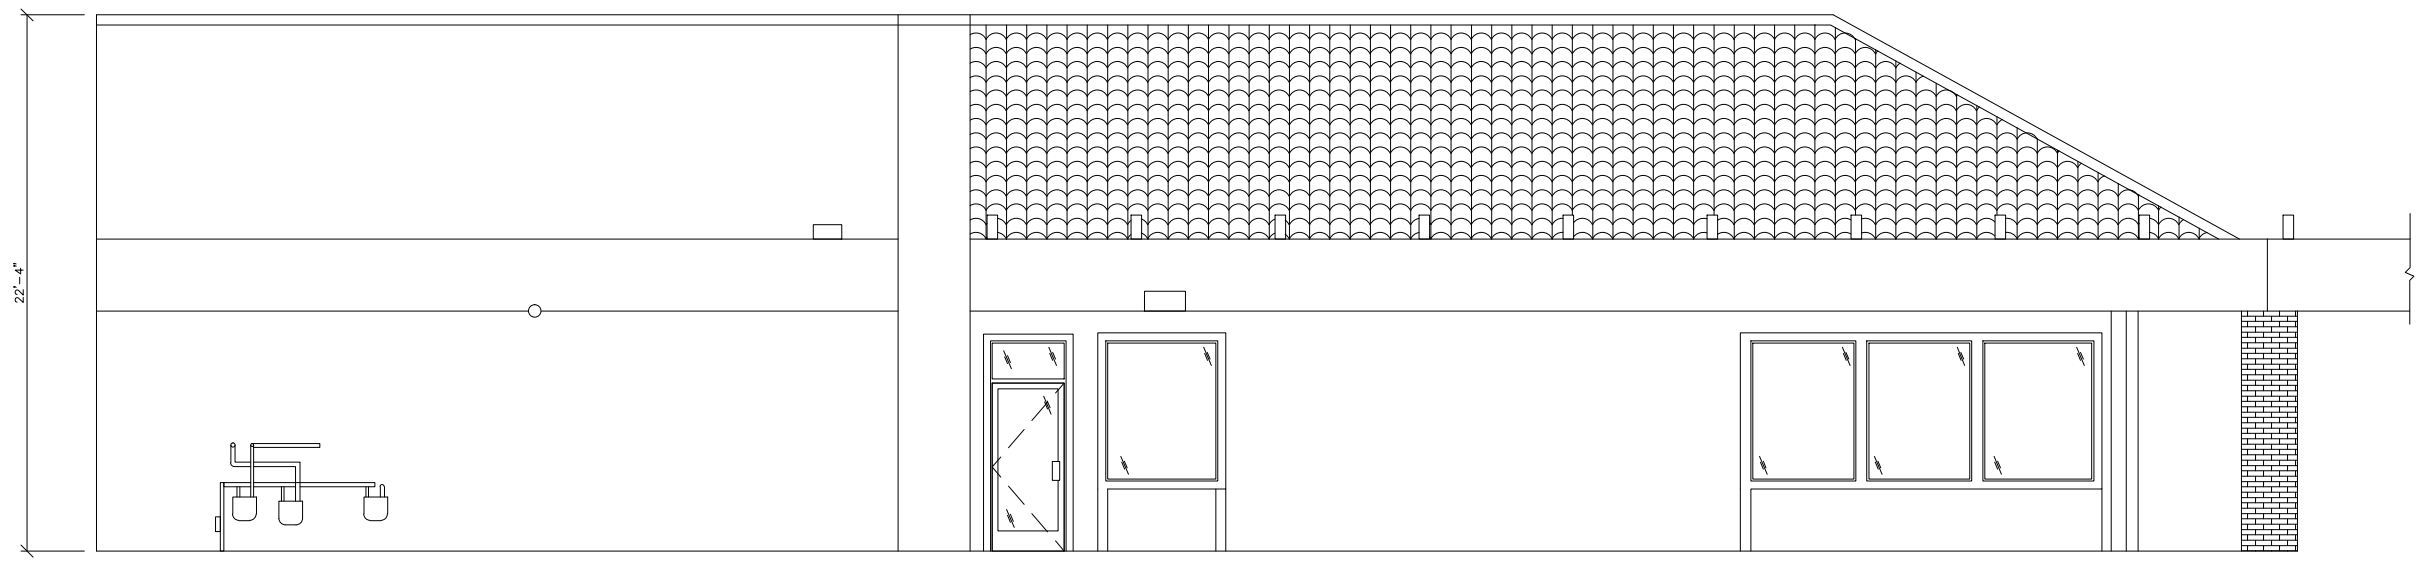

③ BUILDING 4 — NORTH ELEVATION
SCALE: 1/8" = 1'-0"

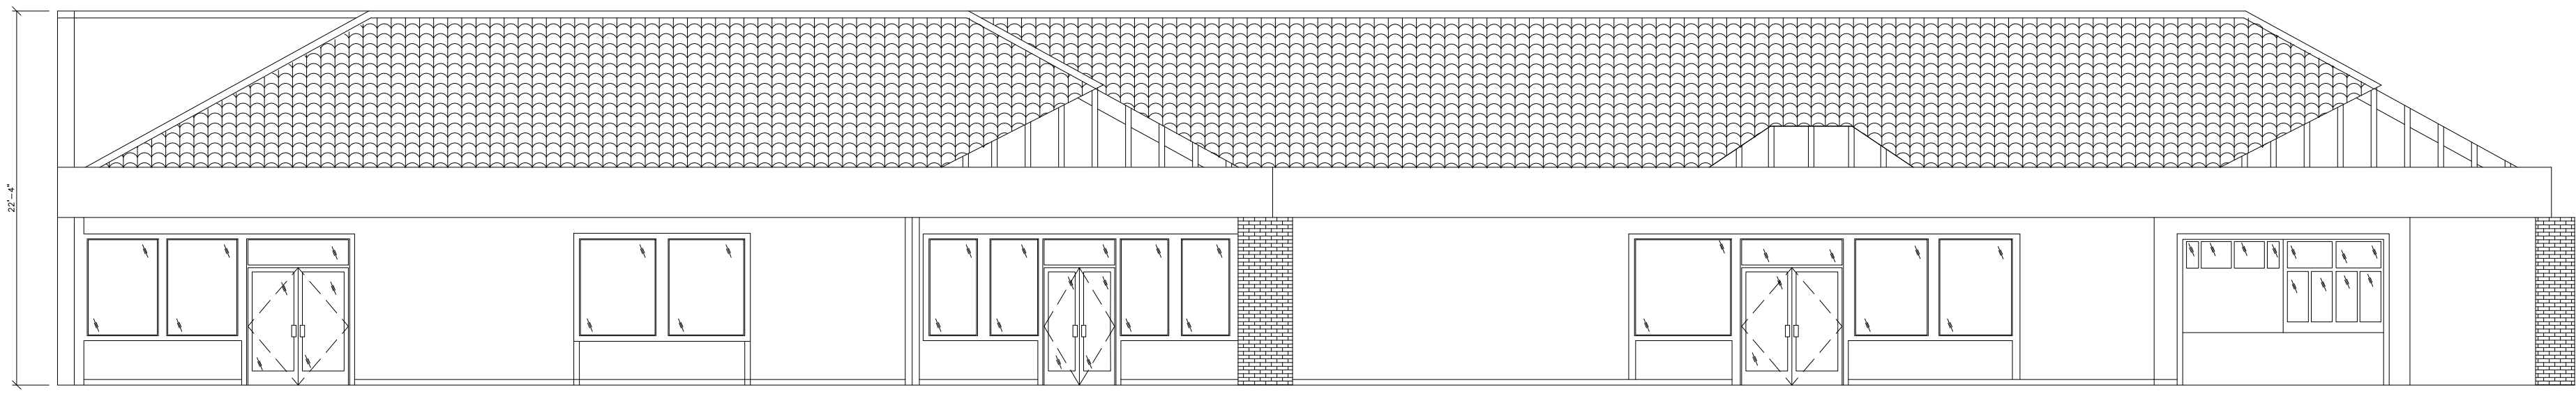

② BUILDING 4 — WEST ELEVATION
SCALE: 1/8" = 1'-0"

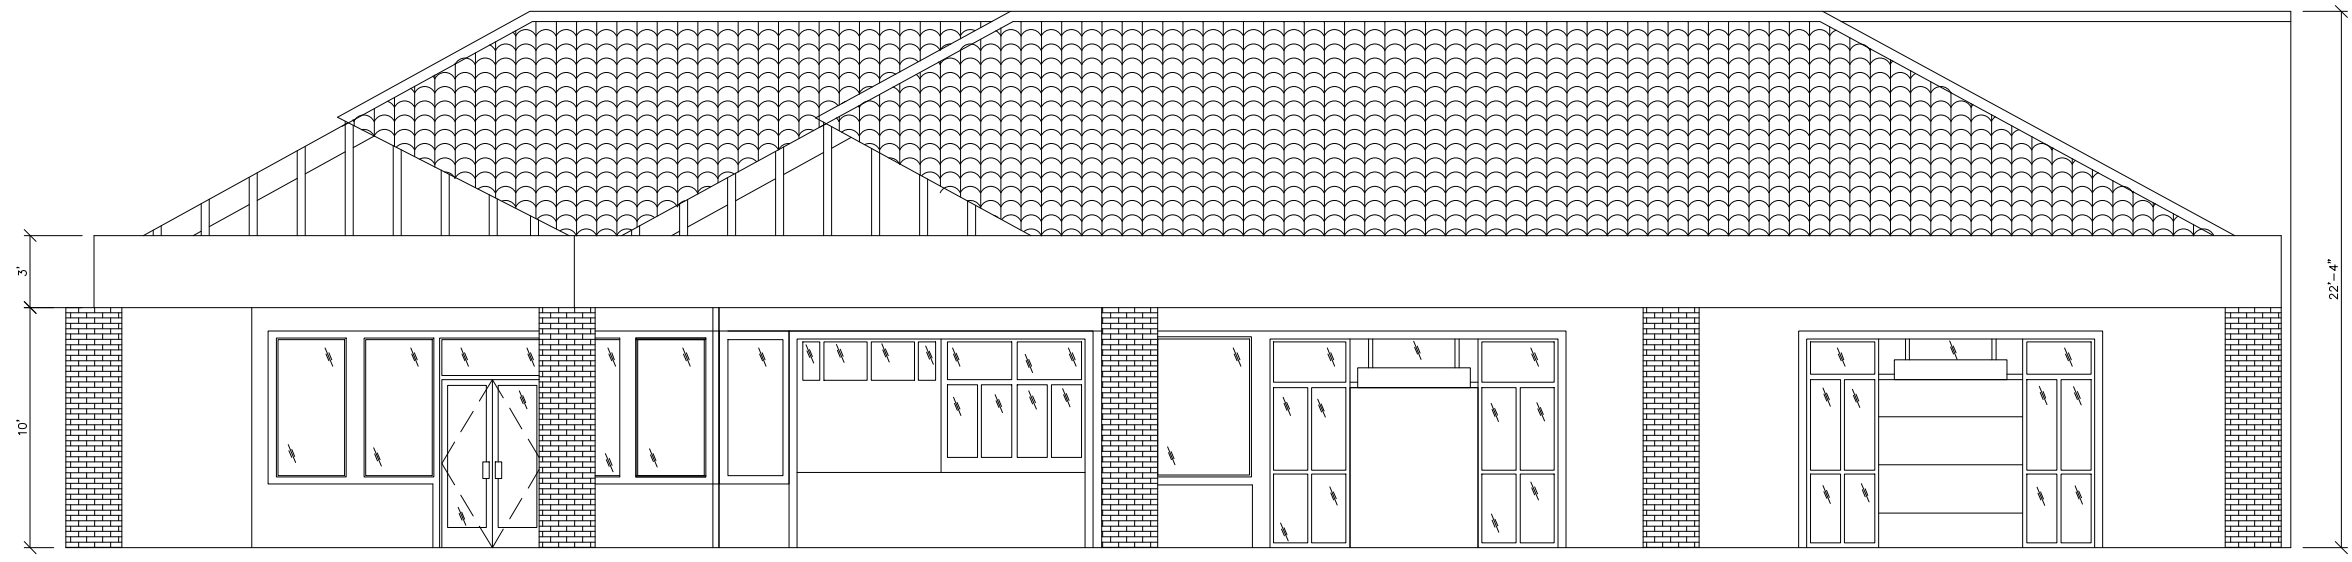

① BUILDING 4 — SOUTH ELEVATION
SCALE: 1/8" = 1'-0"

AS BUILT

PROFESSIONALS

www.asbuiltprofessionals.com

A DIVISION OF:

AEC

CONSULTANTS INC

844.272.8458

844 AS BUILT

© 2021 AEC CONSULTANTS, INC


ARCHITECTURAL AS BUILT
CALA CENTER
SUNNYVALE, CA 94087

1	REVISION	
NO.	ISSUES REVISIONS	DATE
SHEET TITLE		
BUILDING 4 ELEVATIONS		
HL	PROJECT MANAGER	
HL	PROJECT DIRECTOR	
	PROJECT NUMBER	
1/8"=1'-0"		SCALE
MM	DRAWN BY	
AB-17		

ARCHITECTURAL AS BUILT


CALA CENTER

SUNNYVALE, CA 94087

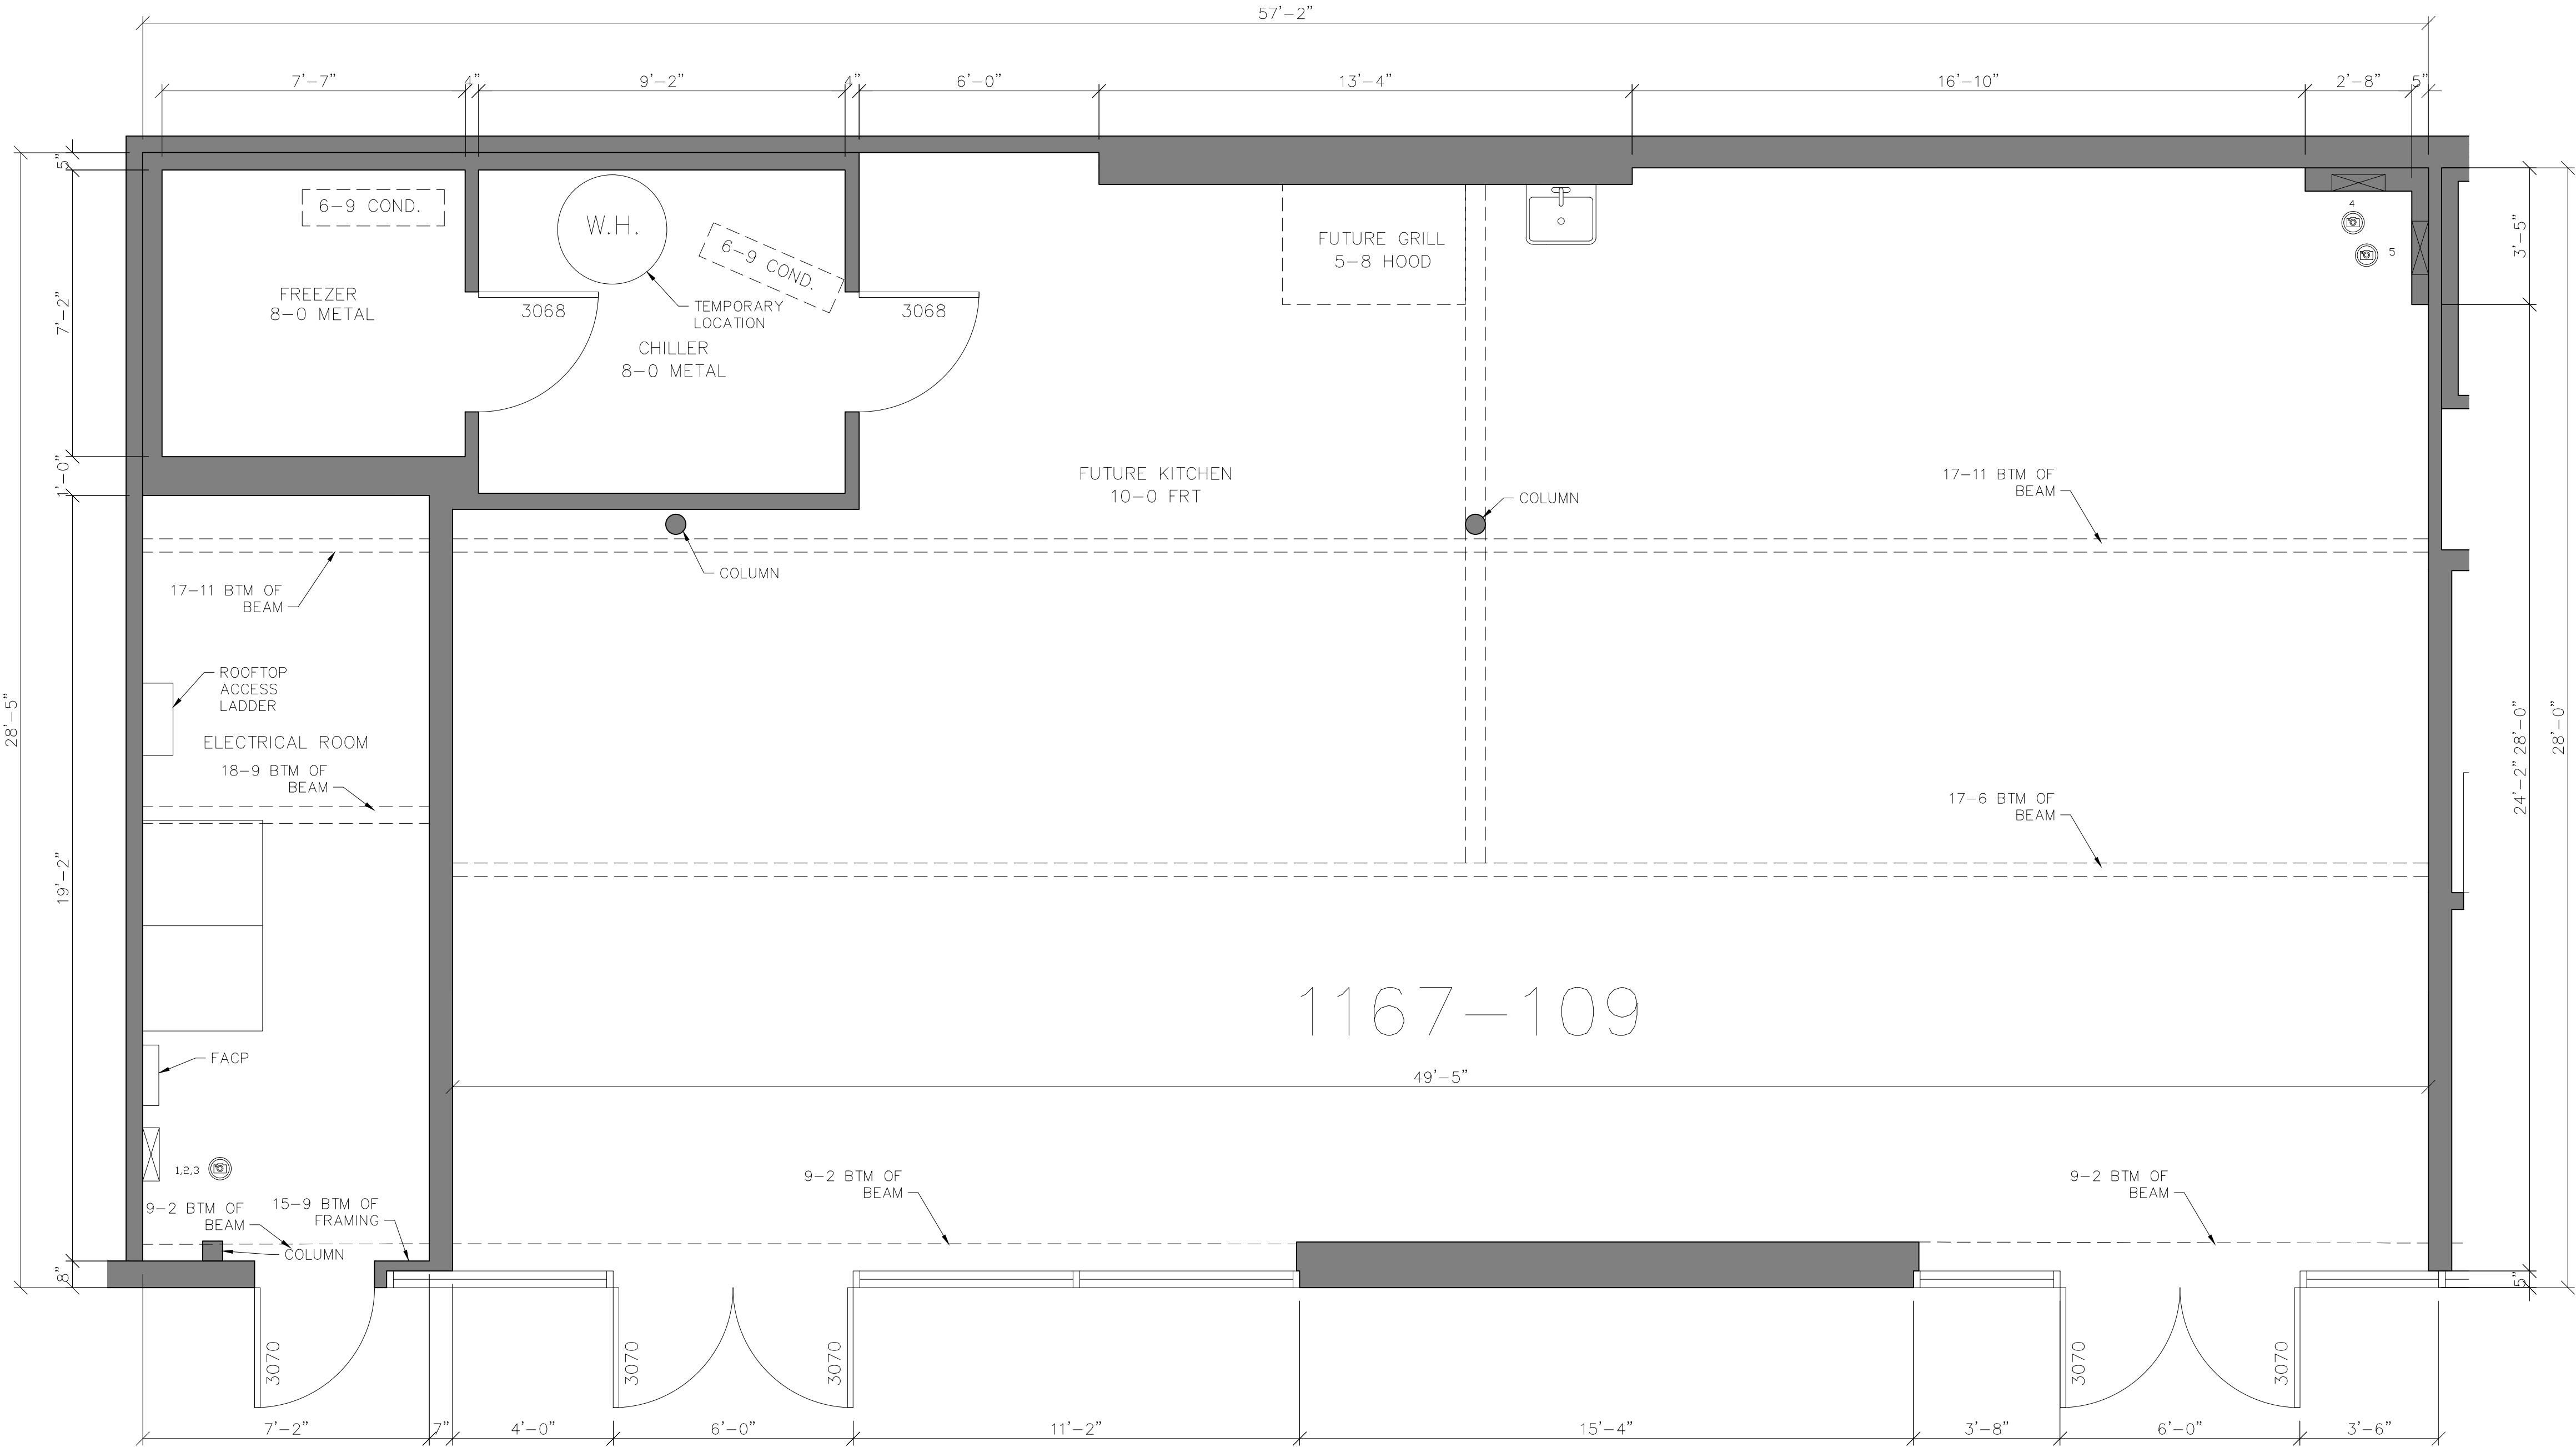

1167-109 — FLOOR PLAN & RCP

SCALE: 3/8" = 1'-0"

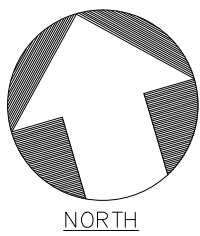


1	REVISION	
NO.	ISSUES REVISIONS	DATE
SHEET TITLE		
1167-109 FLOORPLAN &RCP		
HL	PROJECT MANAGER	
HL	PROJECT DIRECTOR	
	PROJECT NUMBER	
	SCALE	
MM	DRAWN BY	
	SHEET NUMBER	

AB-18

ARCHITECTURAL AS BUILT


CALA CENTER

SUNNYVALE, CA 94087

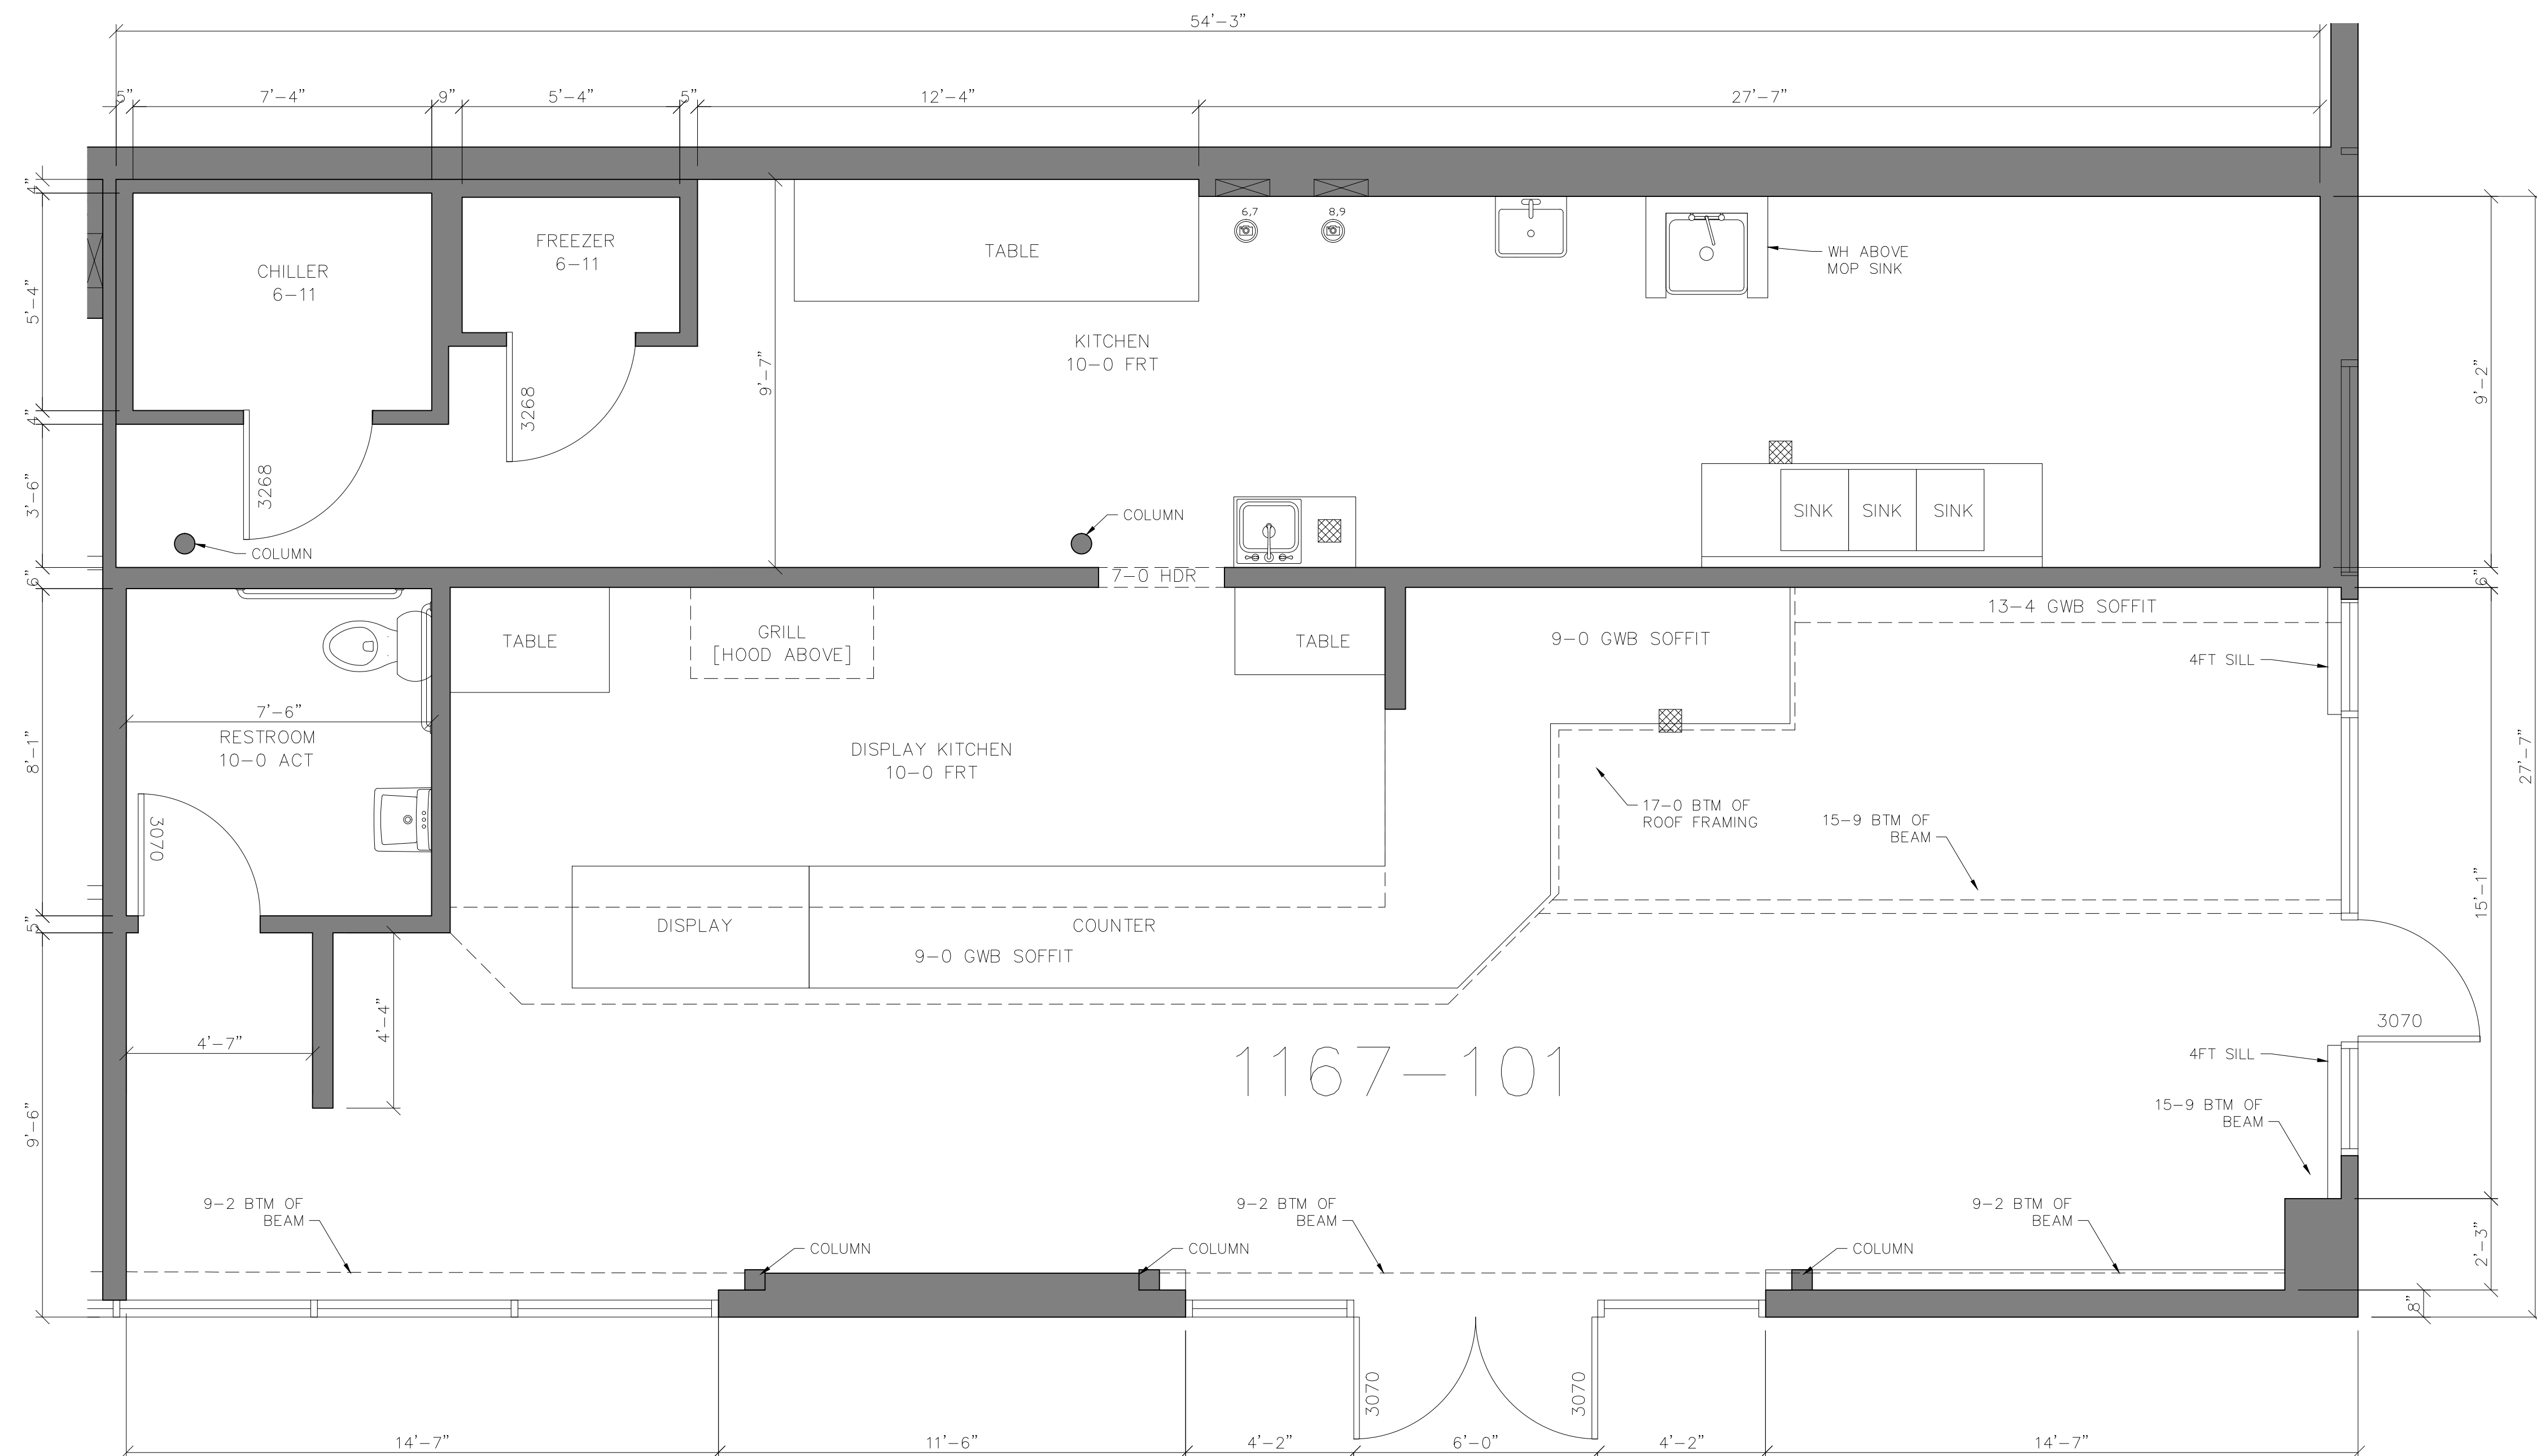

1167-101 - FLOOR PLAN & RCP

SCALE: $3/8" = 1'-0"$

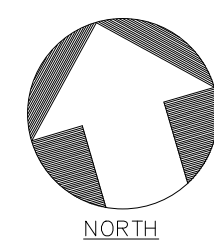


		SHEET TITLE
1167-101 FLOORPLAN &RCP		
HL	PROJECT MANAGER	
HL	PROJECT DIRECTOR	
	PROJECT NUMBER	
3/8"=1'-0"		SCALE
MM	DRAWN BY	
	SHEET NUMBER	

1167-101
LOORPLAN
&RCP

HL	PROJECT MANAGER
HL	PROJECT DIRECTOR
	PROJECT NUMBER
3/8"=1'-0"	SCALE
MM	DRAWN BY
	SHEET NUMBER


AB-19

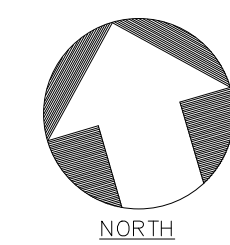

NORTH

ARCHITECTURAL AS BUILT
CALA CENTER
SUNNYVALE, CA 94087

[illegible]

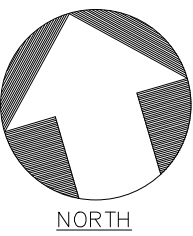

134 – FLOOR PLAN & RCP

SCALE: 1/4" = 1'-0"

AB-22



ARCHITECTURAL AS BUILT
CALA CENTER
SUNNYVALE, CA 94087

1	REVISION	
NO.	ISSUES REVISIONS	DATE
		SHEET TITLE
133 FLOORPLAN &RCP		
HL		PROJECT MANAGER
HL		PROJECT DIRECTOR
		PROJECT NUMBER
1/4"=1'-0"		SCALE
MM		DRAWN BY
		SHEET NUMBER
AB-23		

ARCHITECTURAL AS BUILT
CALA CENTER
SUNNYVALE, CA 94087

[illegible]


1	REVISION	
NO.	ISSUES REVISIONS	DATE

ET TITLE

131
FLOORPLAN
&RCP


HL	PROJECT MANAGER
HL	PROJECT DIRECTOR
	PROJECT NUMBER
1/4"=1'-0"	SCALE
MM	DRAWN BY

AB-24

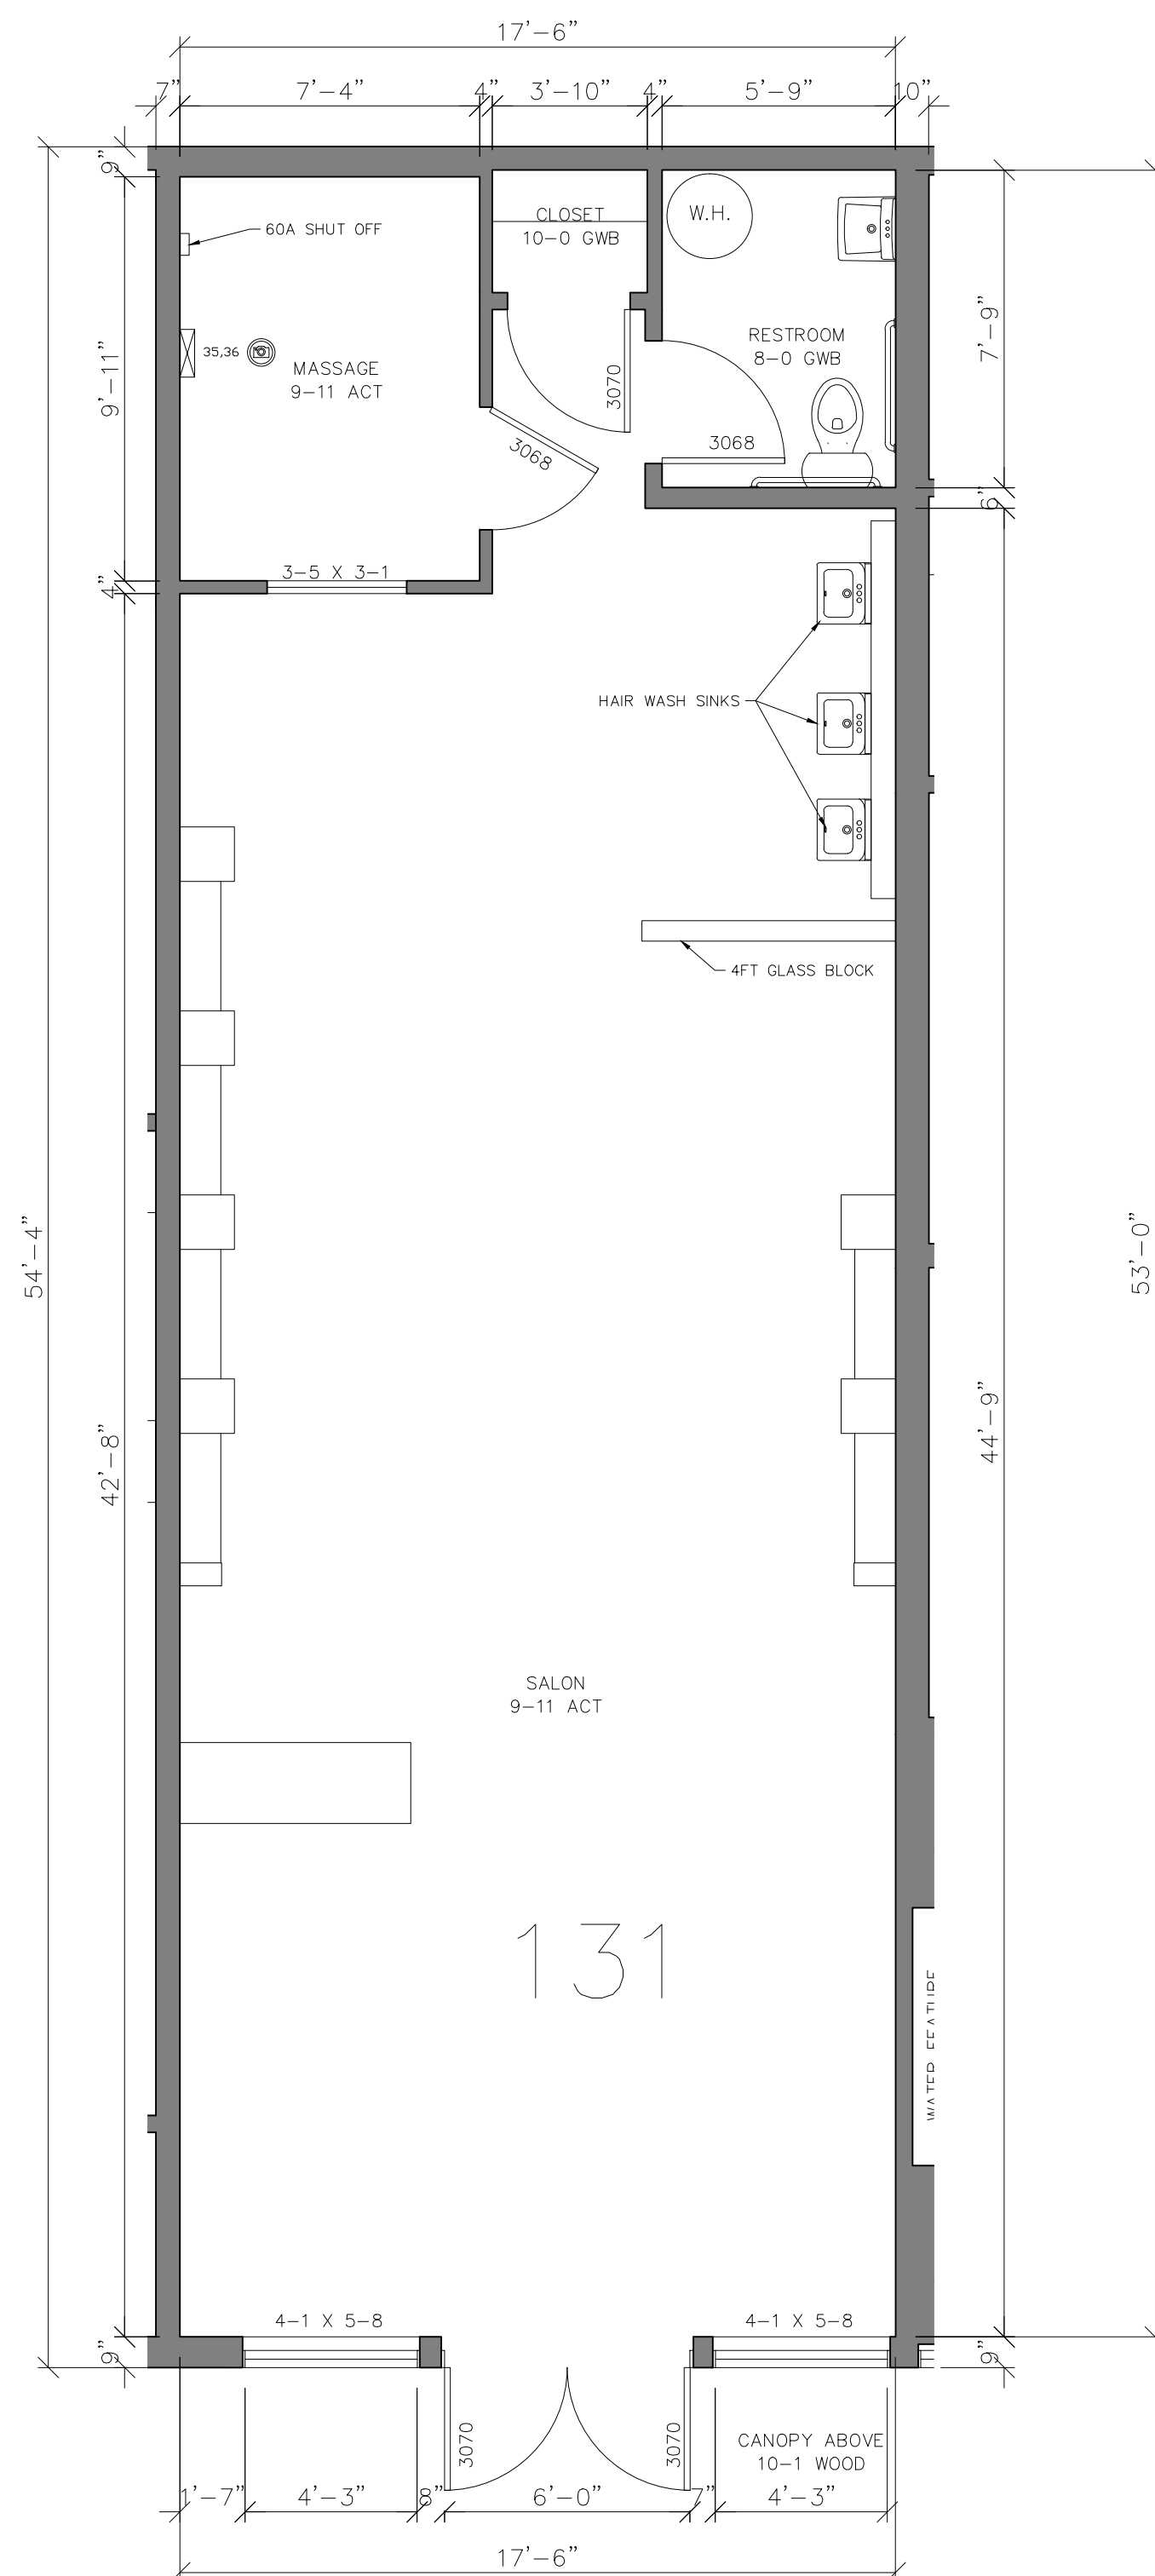

131 – FLOOR PLAN & RCP

SCALE: $1/4" = 1'-0"$

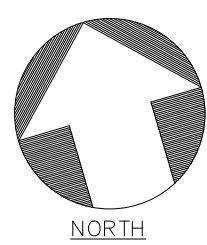



© 2021 AEC CONSULTANTS INC

ARCHITECTURAL AS BUILT
CALA CENTER
SUNNYVALE, CA 94087


1	REVISION	
NO.	ISSUES REVISIONS	DATE

PROJECT TITLE

129
FLOORPLAN
&RCP


HL	PROJECT MANAGER
HL	PROJECT DIRECTOR
	PROJECT NUMBER
1/4"=1'-0"	SCALE
MM	DRAWN BY
	SHEET NUMBER

AB-25

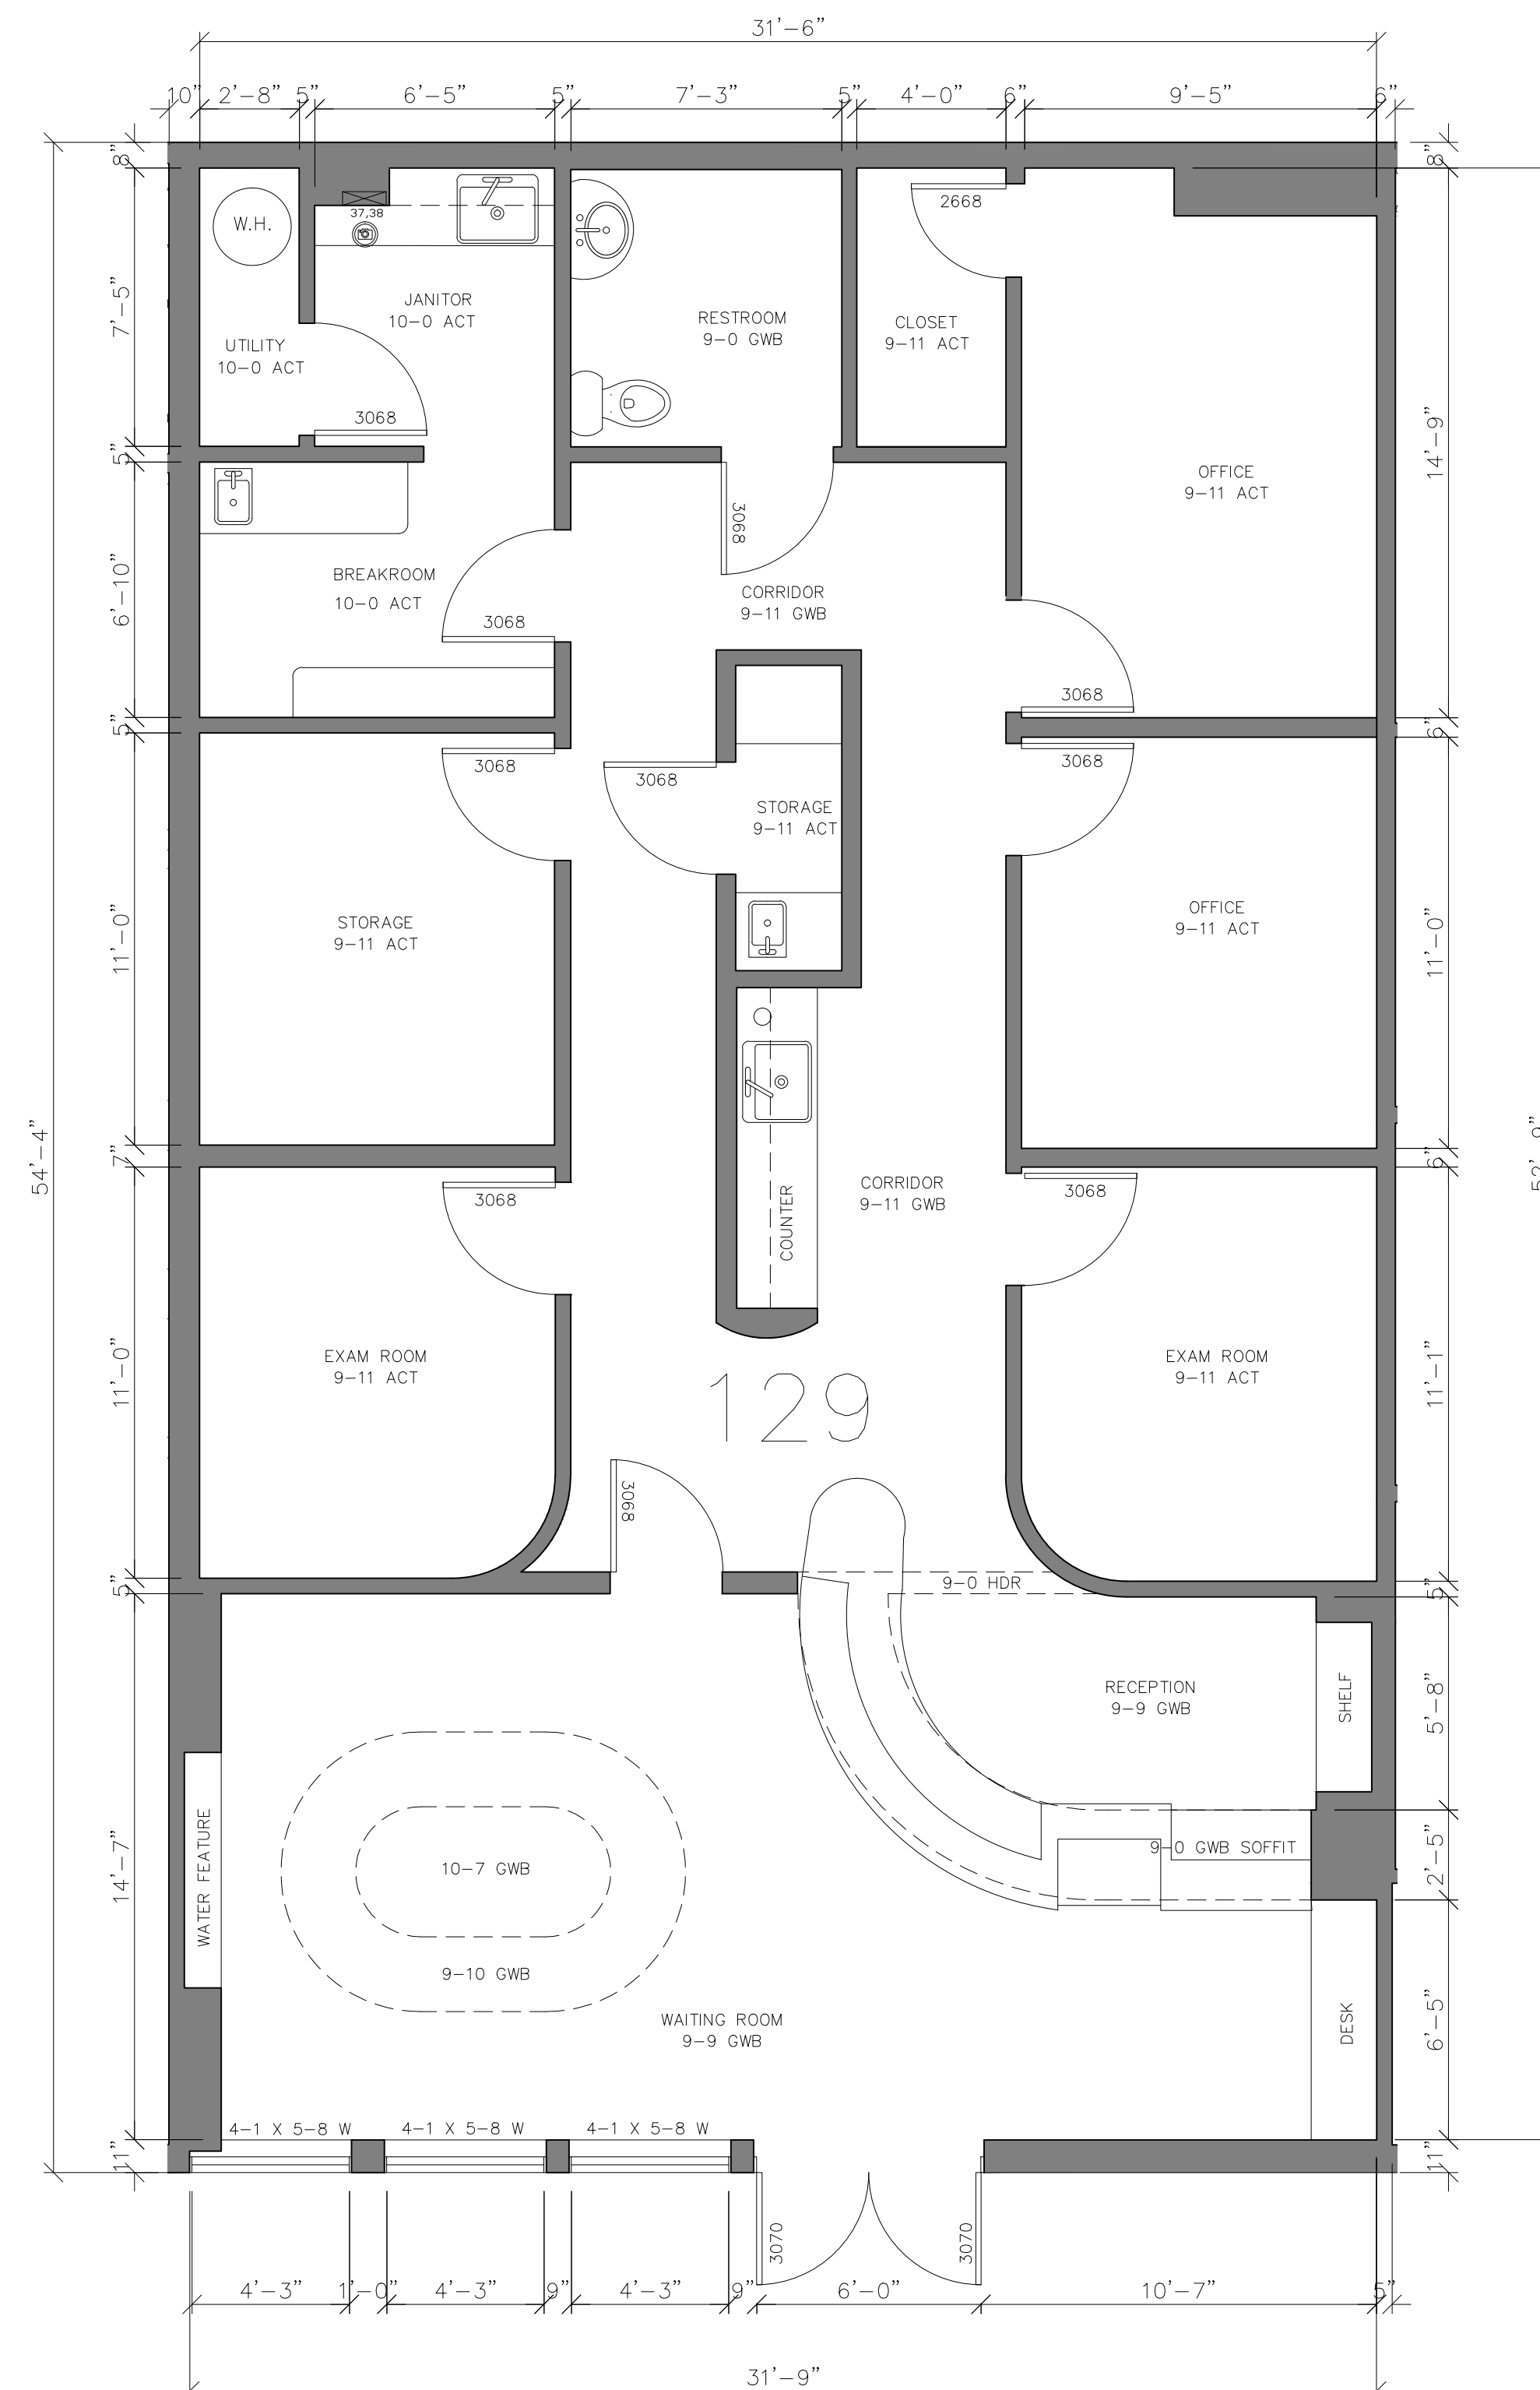

129 – FLOOR PLAN & RCP

SCALE: $1/4" = 1'-0"$

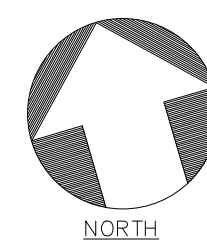

ARCHITECTURAL AS BUILT
CALA CENTER
SUNNYVALE, CA 94087

[illegible]


1	REVISION	
NO.	ISSUES REVISIONS	DATE
		SHEET TITLE

ET TITLE

127
FLOORPLAN
&RCP


HL	PROJECT MANAGER
HL	PROJECT DIRECTOR
	PROJECT NUMBER
1/4"=1'-0"	SCALE
MM	DRAWN BY
	SHEET NUMBER

AB-26

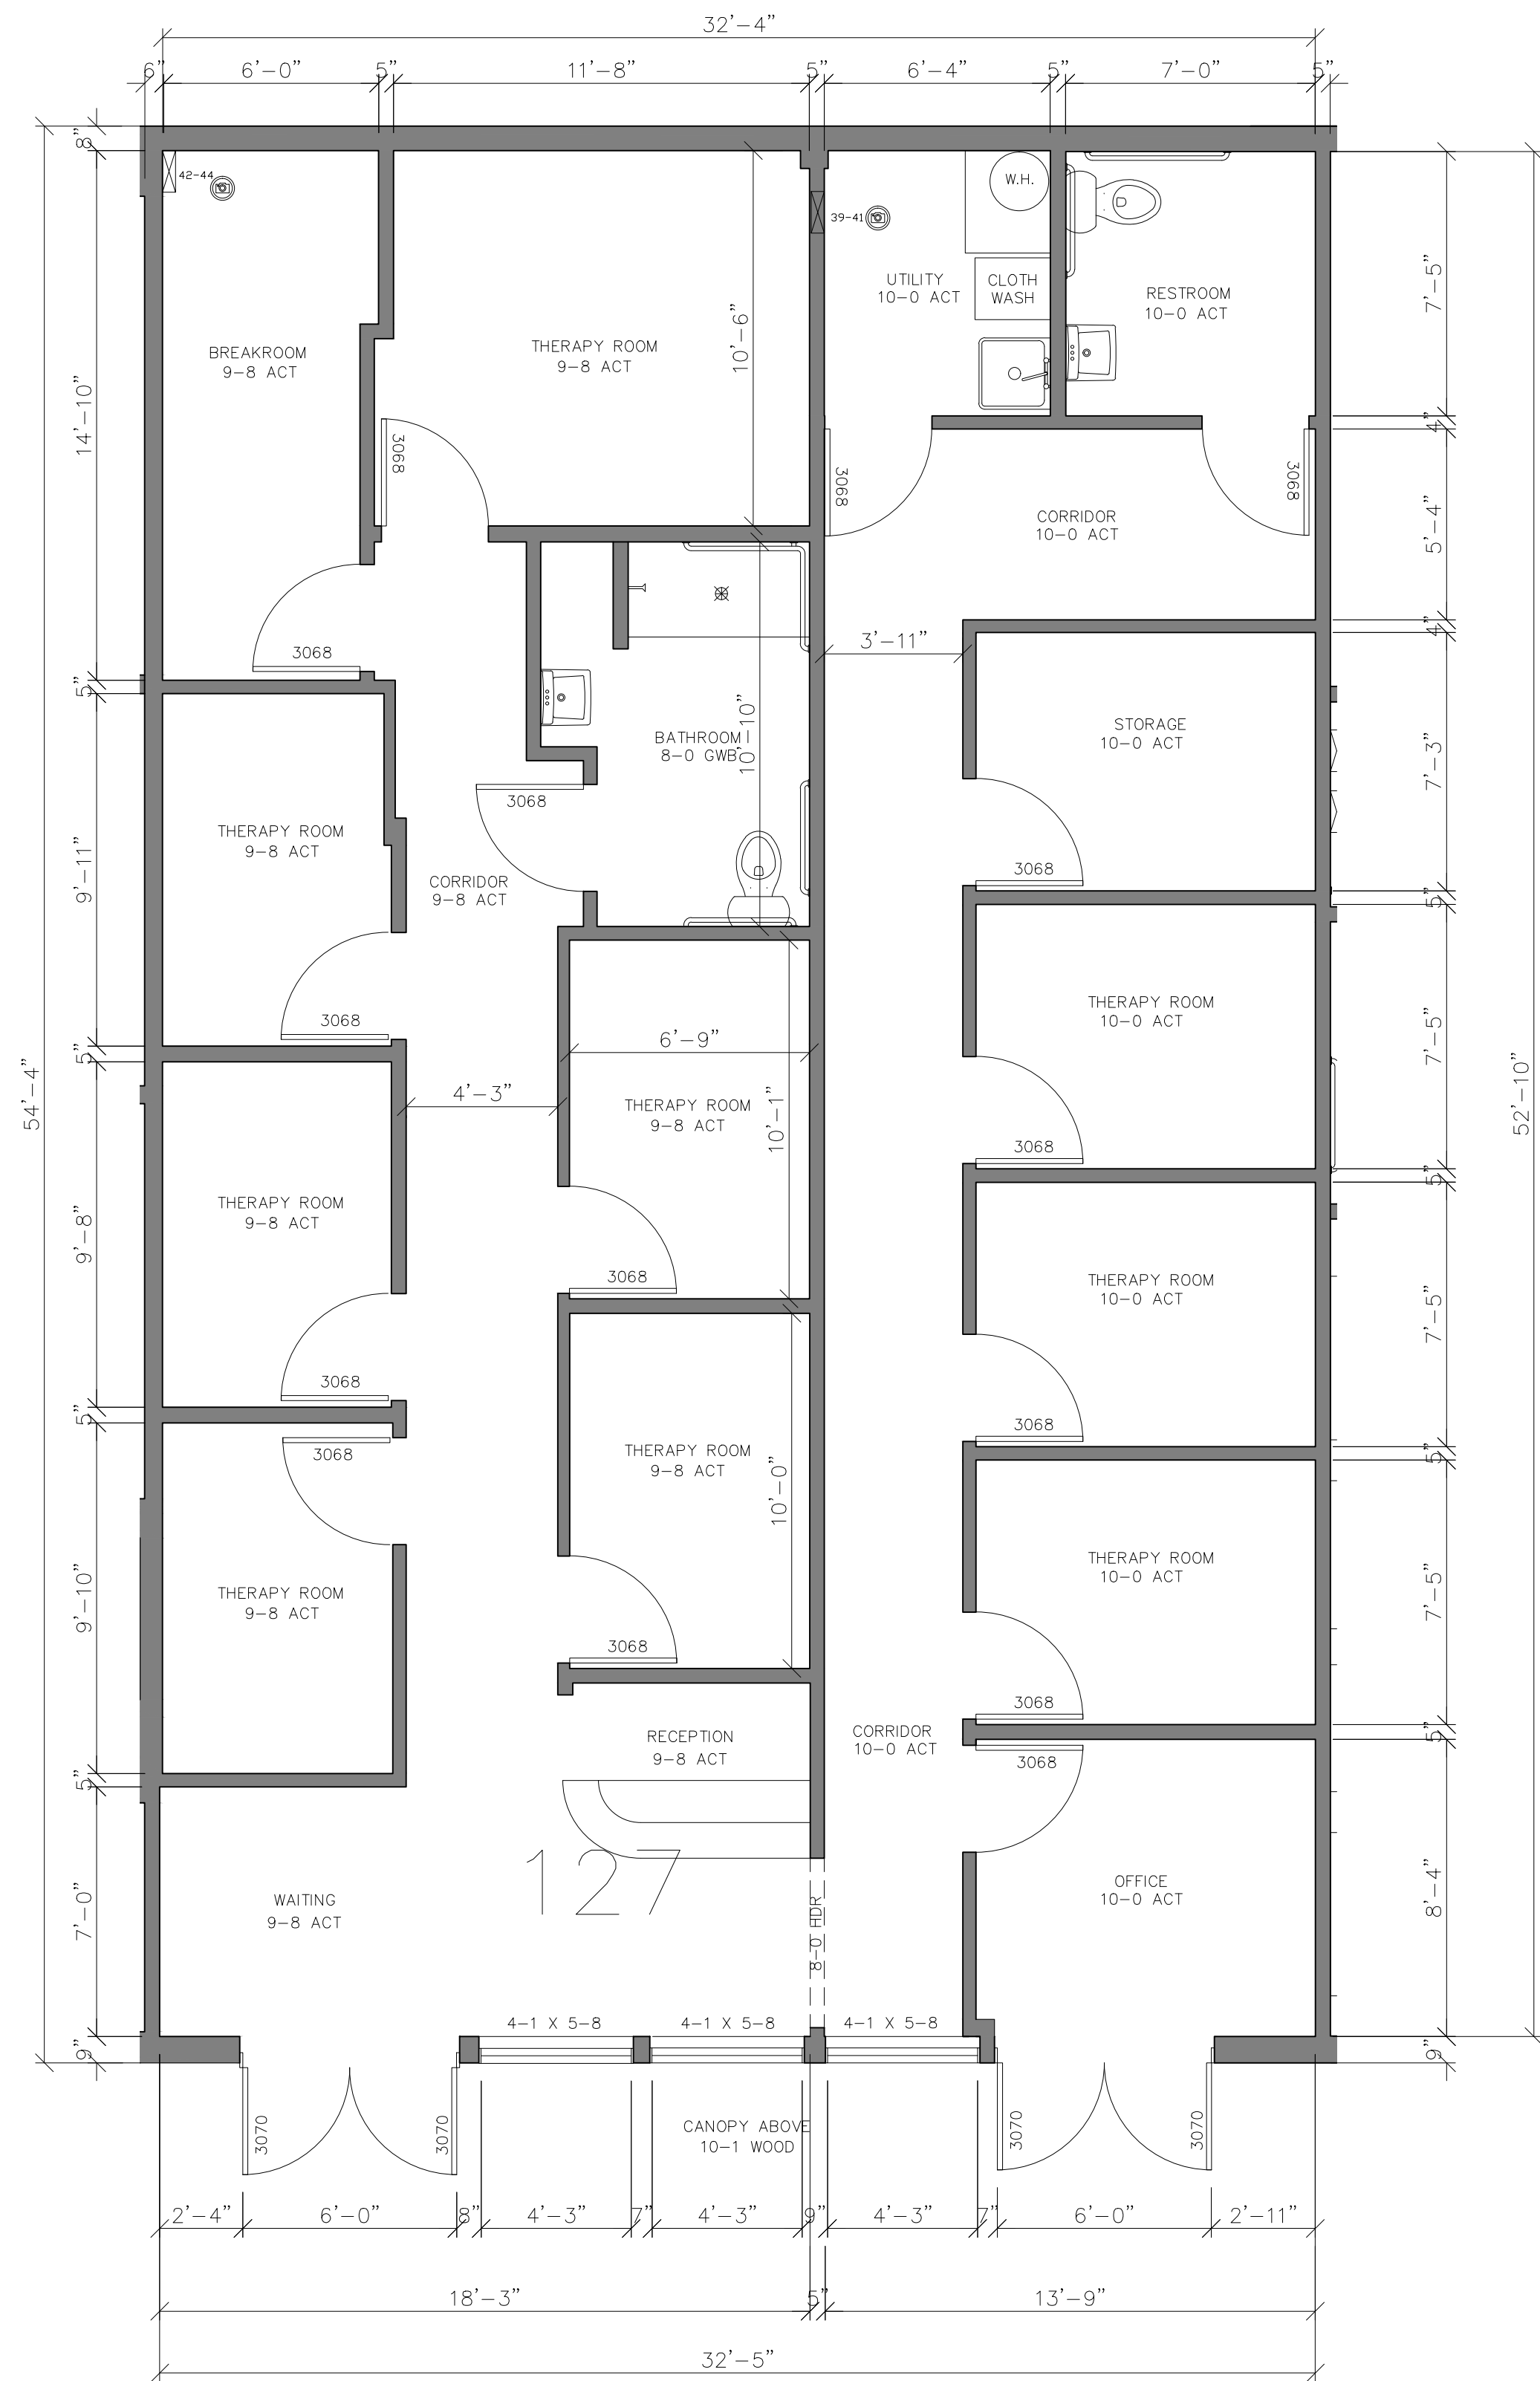

127 – FLOOR PLAN & RCP


SCALE: $1/4" = 1'-0"$

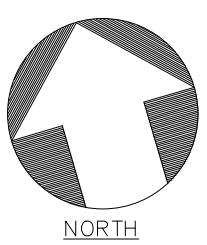

ARCHITECTURAL AS BUILT


CALA CENTER

SUNNYVALE, CA 94087

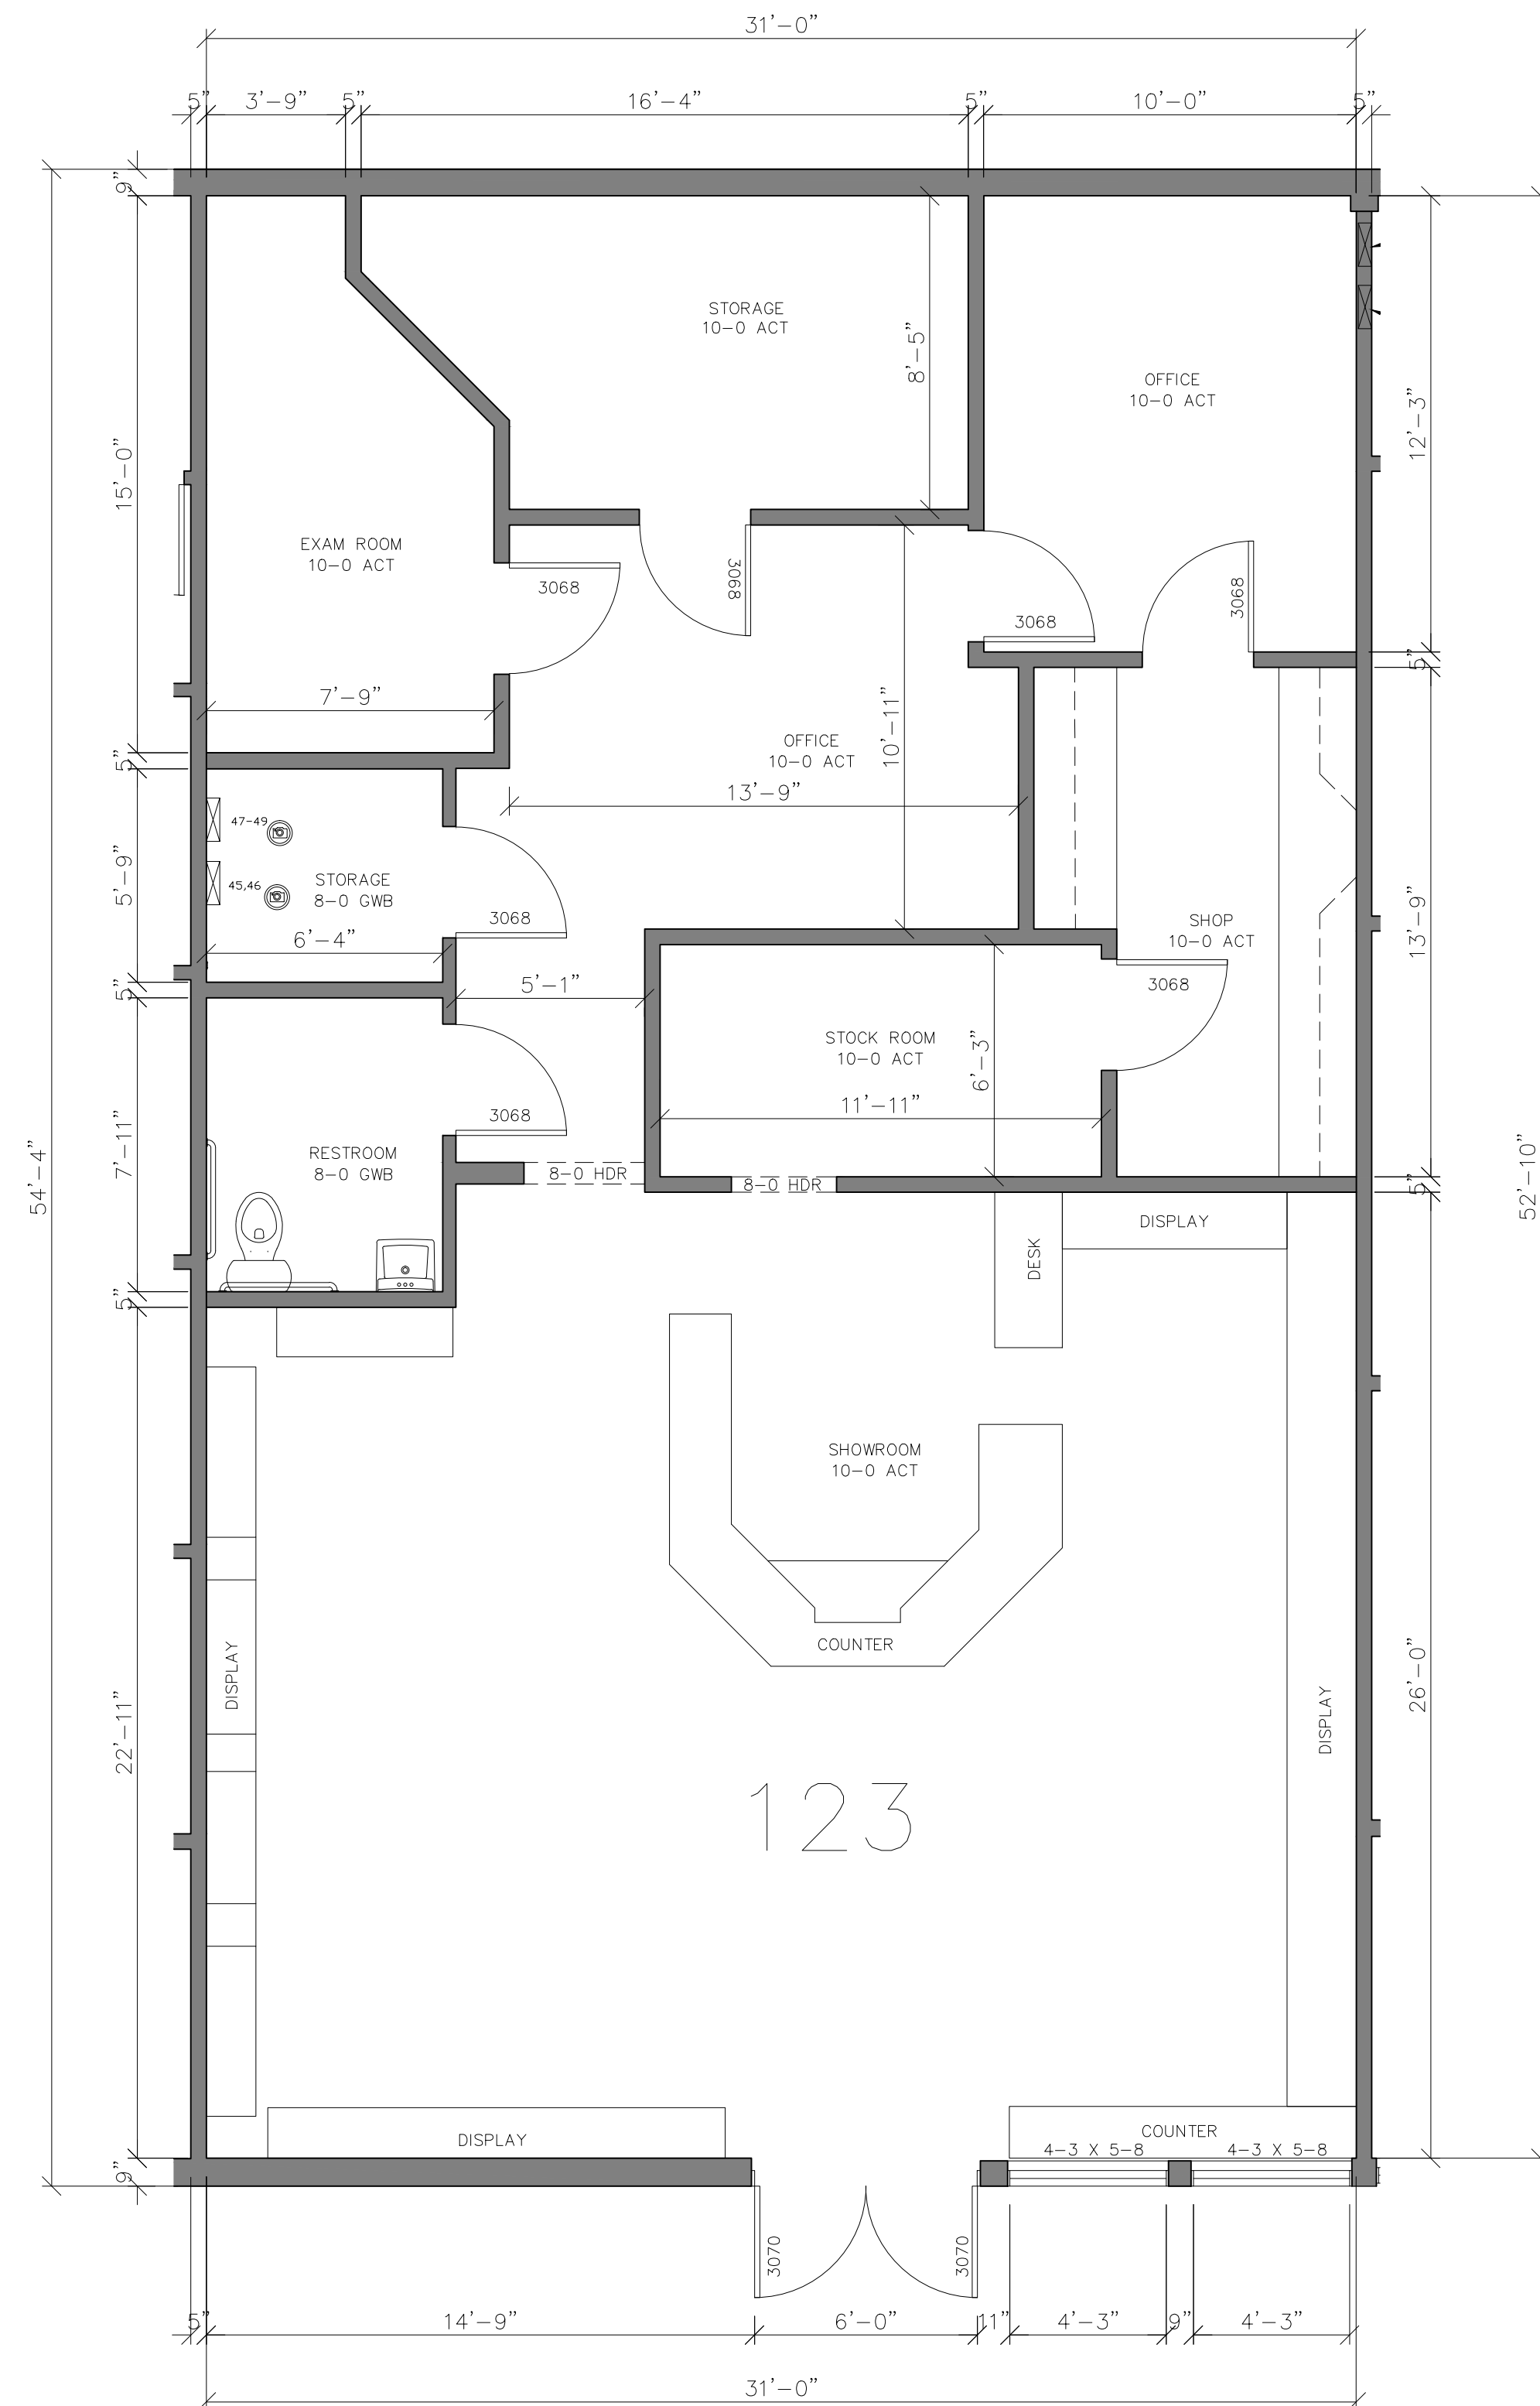

123 – FLOOR PLAN & RCP

SCALE: $1/4" = 1'-0"$

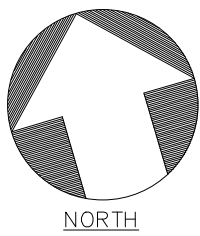

1	REVISION	
NO.	ISSUES REVISIONS	DATE
		SHEET TITLE
123 FLOORPLAN &RCP		
HL		PROJECT MANAGER
HL		PROJECT DIRECTOR
		PROJECT NUMBER
1/4"=1'-0"		SCALE
MM		DRAWN BY
		SHEET NUMBER

AB-27

[illegible]

HL	PROJECT MANAGER
HL	PROJECT DIRECTOR
	PROJECT NUMBER
1/4"=1'-0"	SCALE
MM	DRAWN BY
	SHEET NUMBER



NORTH



ARCHITECTURAL AS BUILT

CALA CENTER
SUNNYVALE, CA 94087

[illegible]

1	REVISION	
NO.	ISSUES REVISIONS	DATE

SHEET TITLE

117
FLOORPLAN
&RCP

HI	PROJECT MANAGER
----	-----------------

HL	PROJECT DIRECTOR
----	------------------


PROJECT NUMBER

1/4"=1'-0" SCALE

MM	DRAWN BY
----	----------


SHEET NUMBER

AB-29

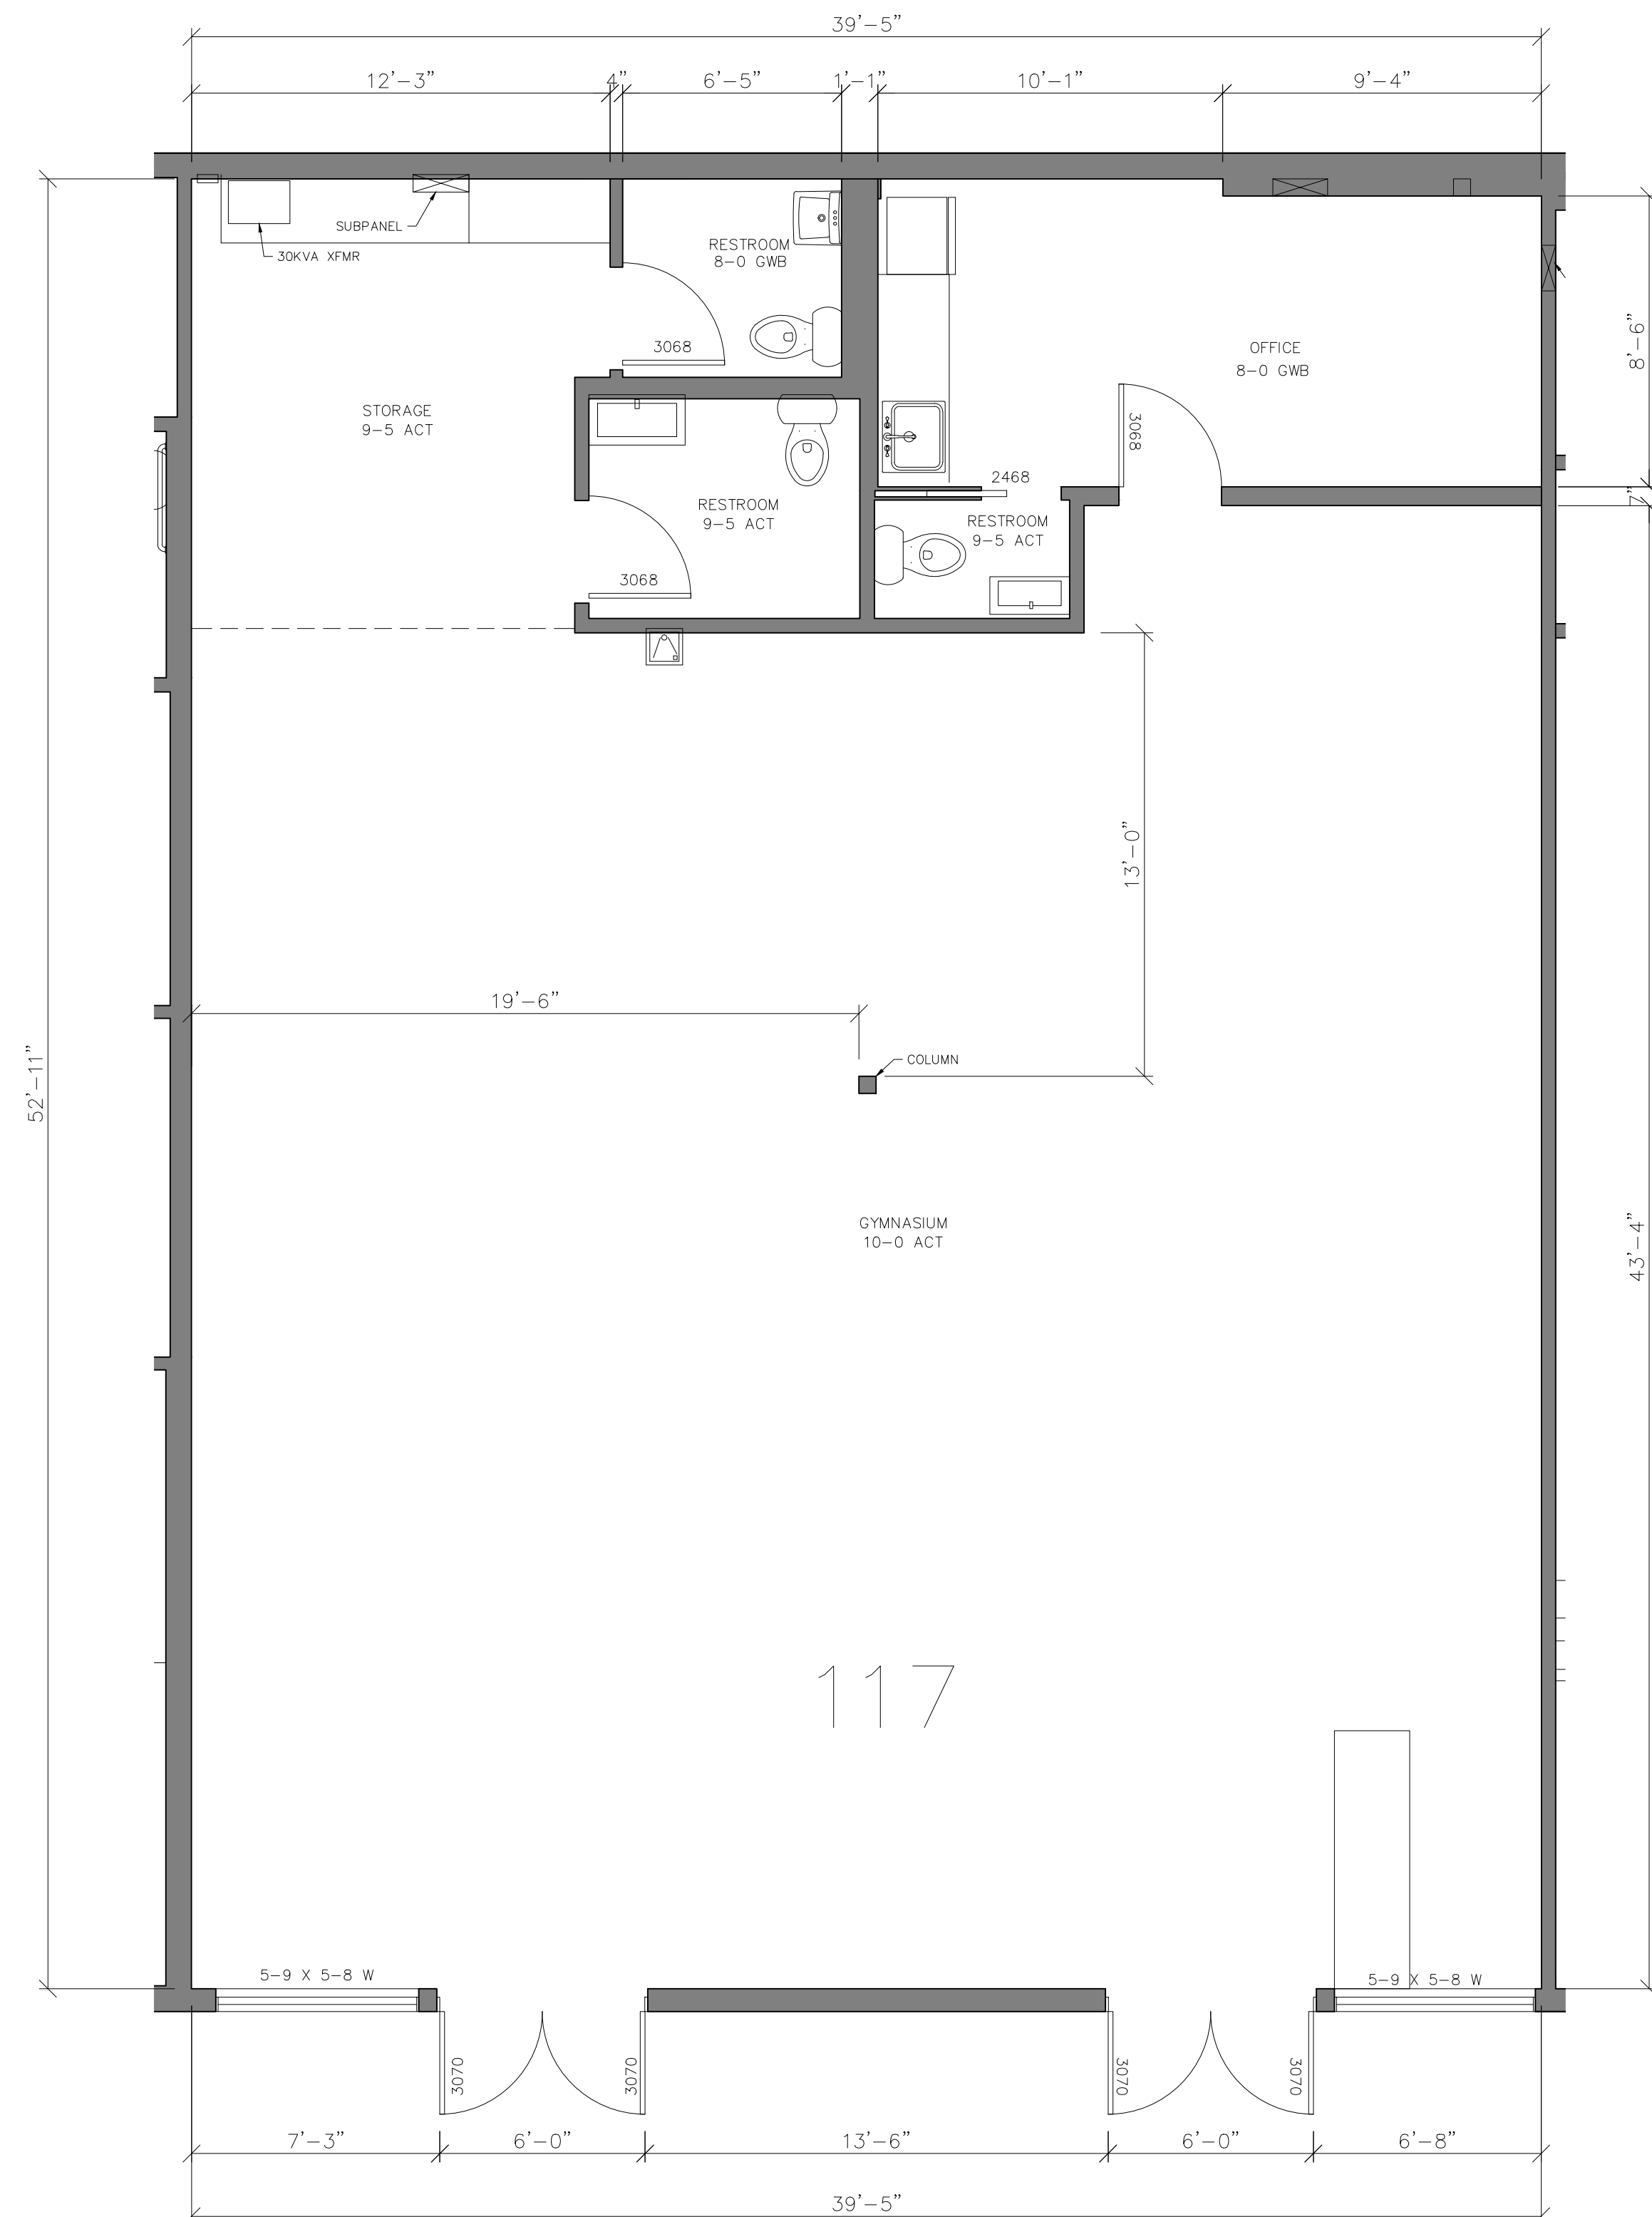

117 – FLOOR PLAN & RCP

SCALE: $1/4" = 1'-0"$

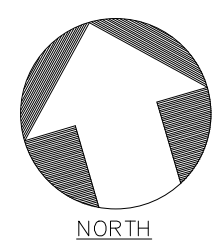

ARCHITECTURAL AS BUILT

CALA CENTER
SUNNYVALE, CA 94087

[illegible]


1	REVISION	
NO.	ISSUES REVISIONS	DATE

NET TITLE

115
FLOORPLAN
&RCP


HL	PROJECT MANAGER
HL	PROJECT DIRECTOR
	PROJECT NUMBER
1/4"=1'-0"	SCALE
MM	DRAWN BY
	SHEET NUMBER

AB-30

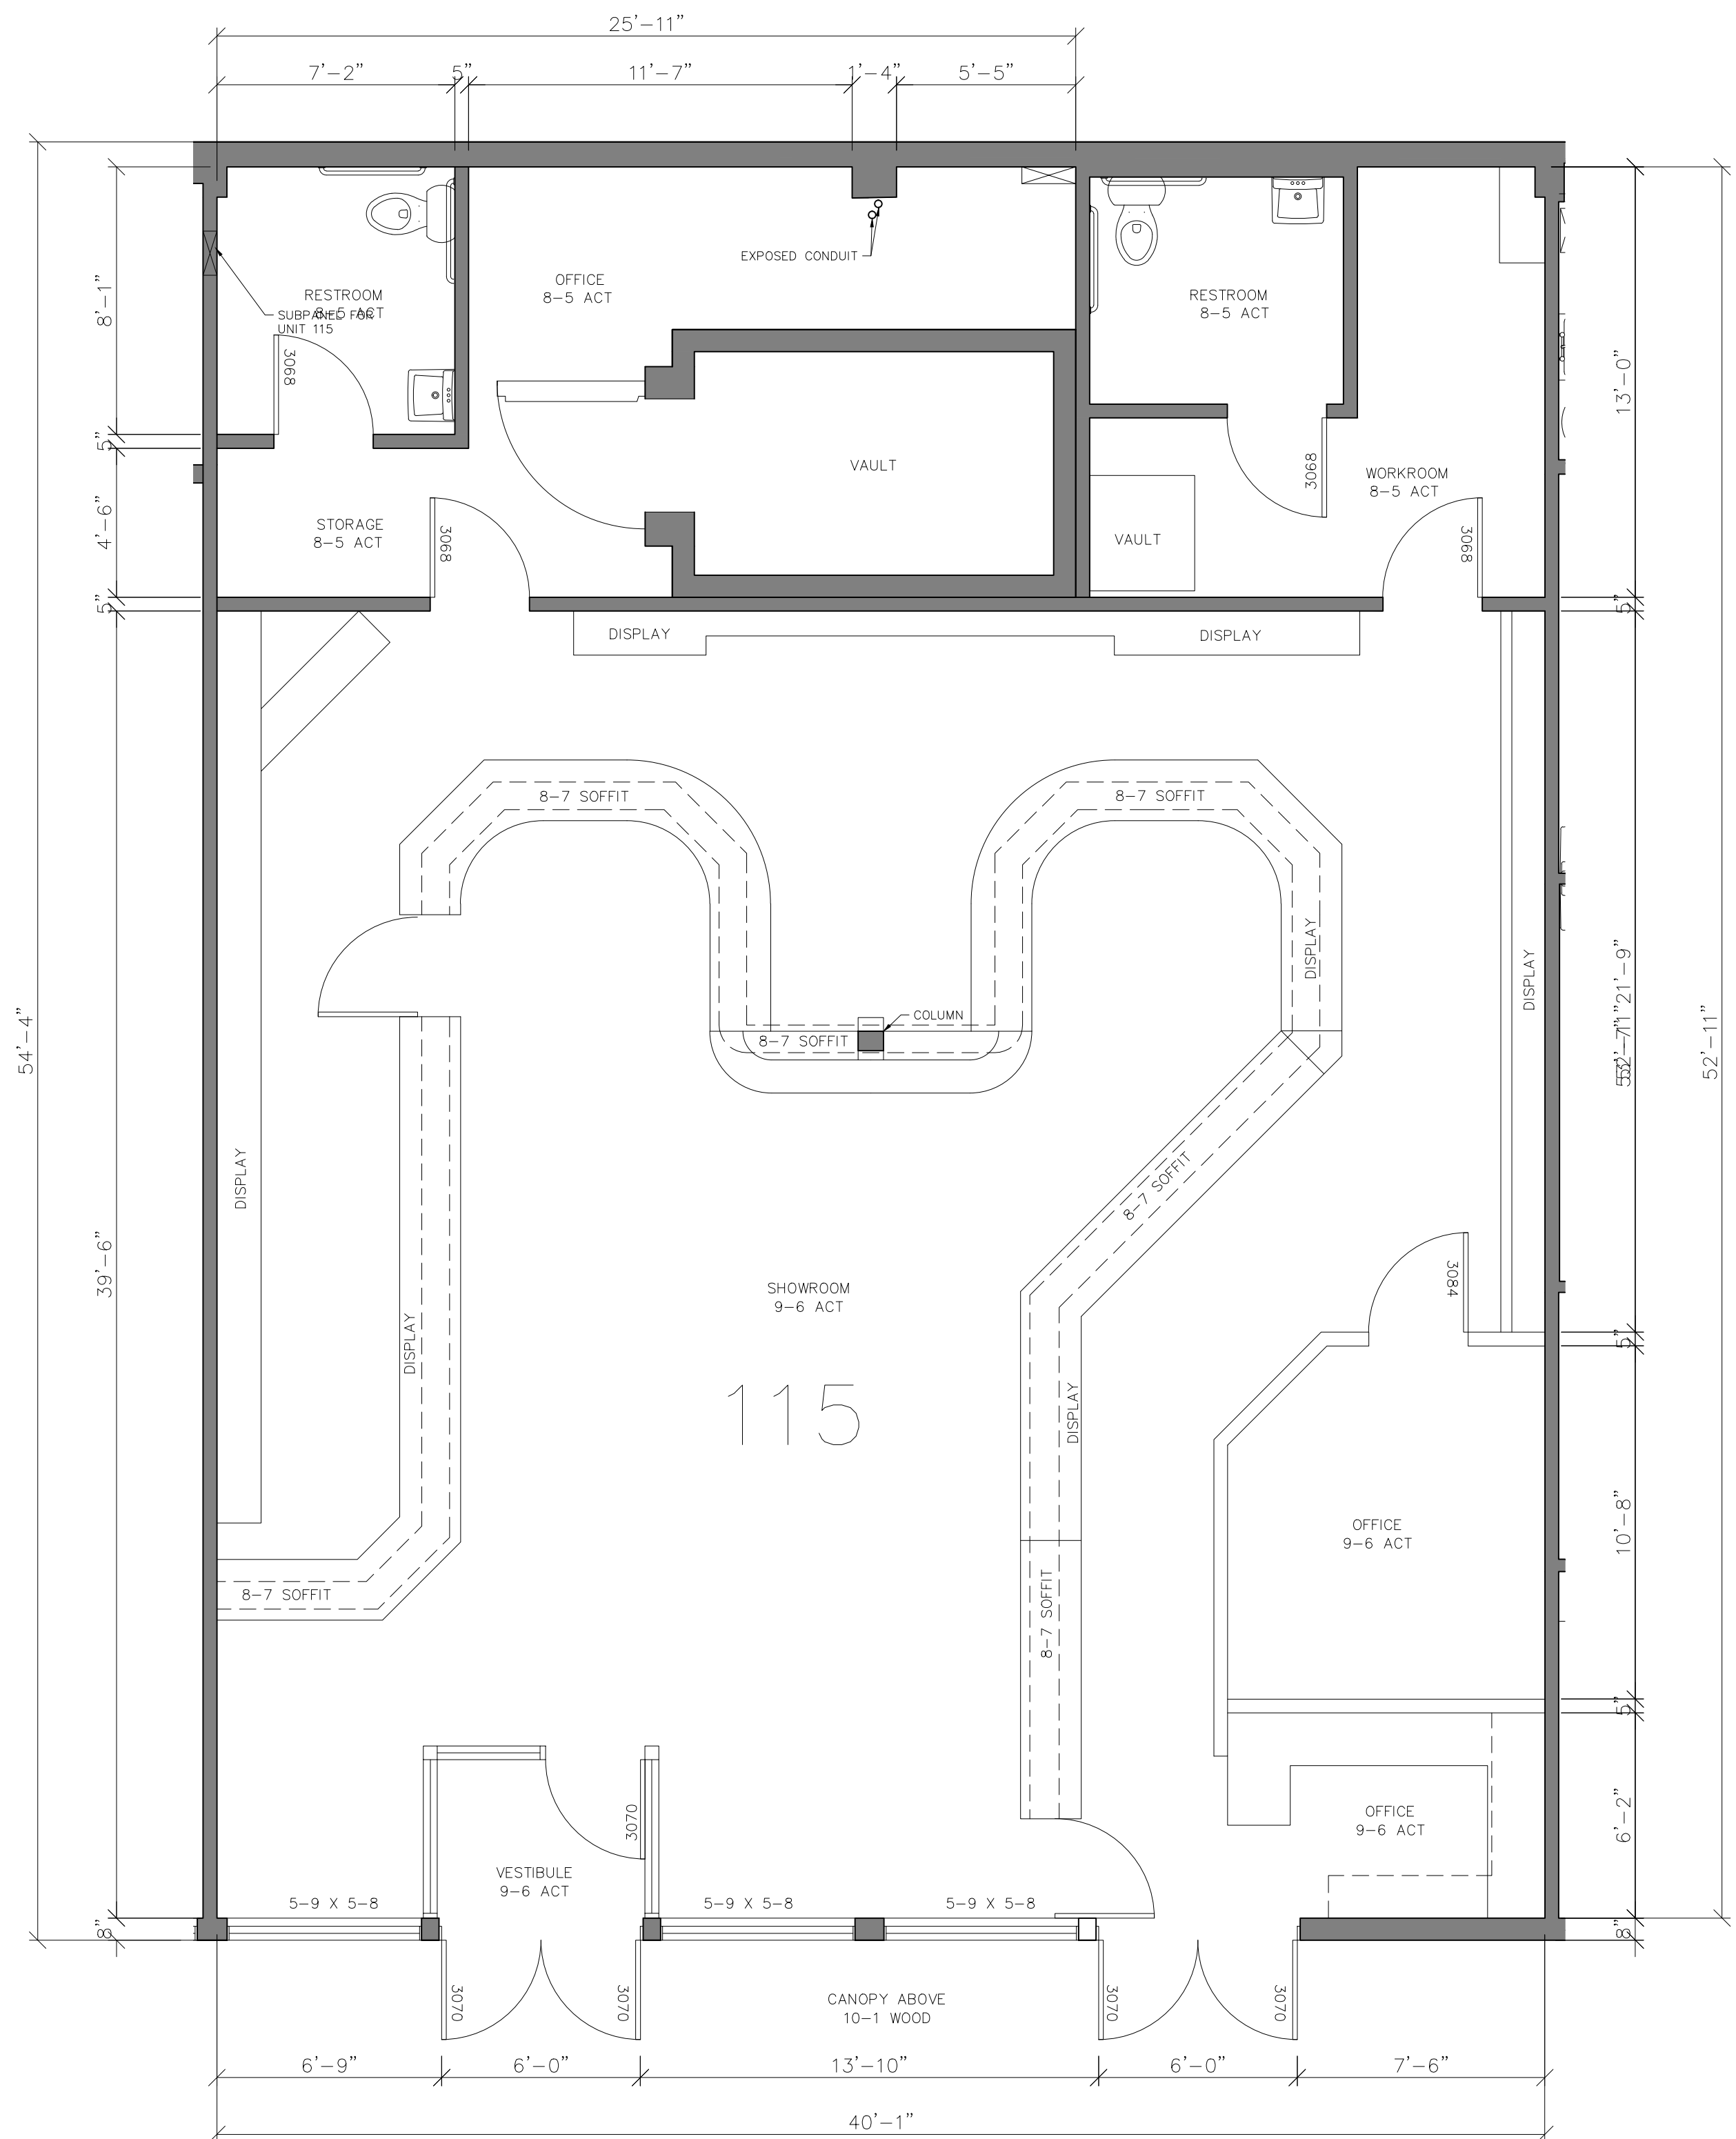


115 – FLOOR PLAN & RCP

SCALE: $1/4" = 1'-0"$

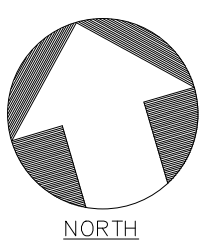




SHEET TITLE	
111 FLOORPLAN &RCP	
HL	PROJECT MANAGER
HL	PROJECT DIRECTOR
	PROJECT NUMBER
1/4"=1'-0"	
MM	SCALE
	DRAWN BY
	SHEET NUMBER

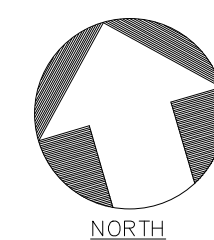


ARCHITECTURAL AS BUILT

CALA CENTER
SUNNYVALE, CA 94087

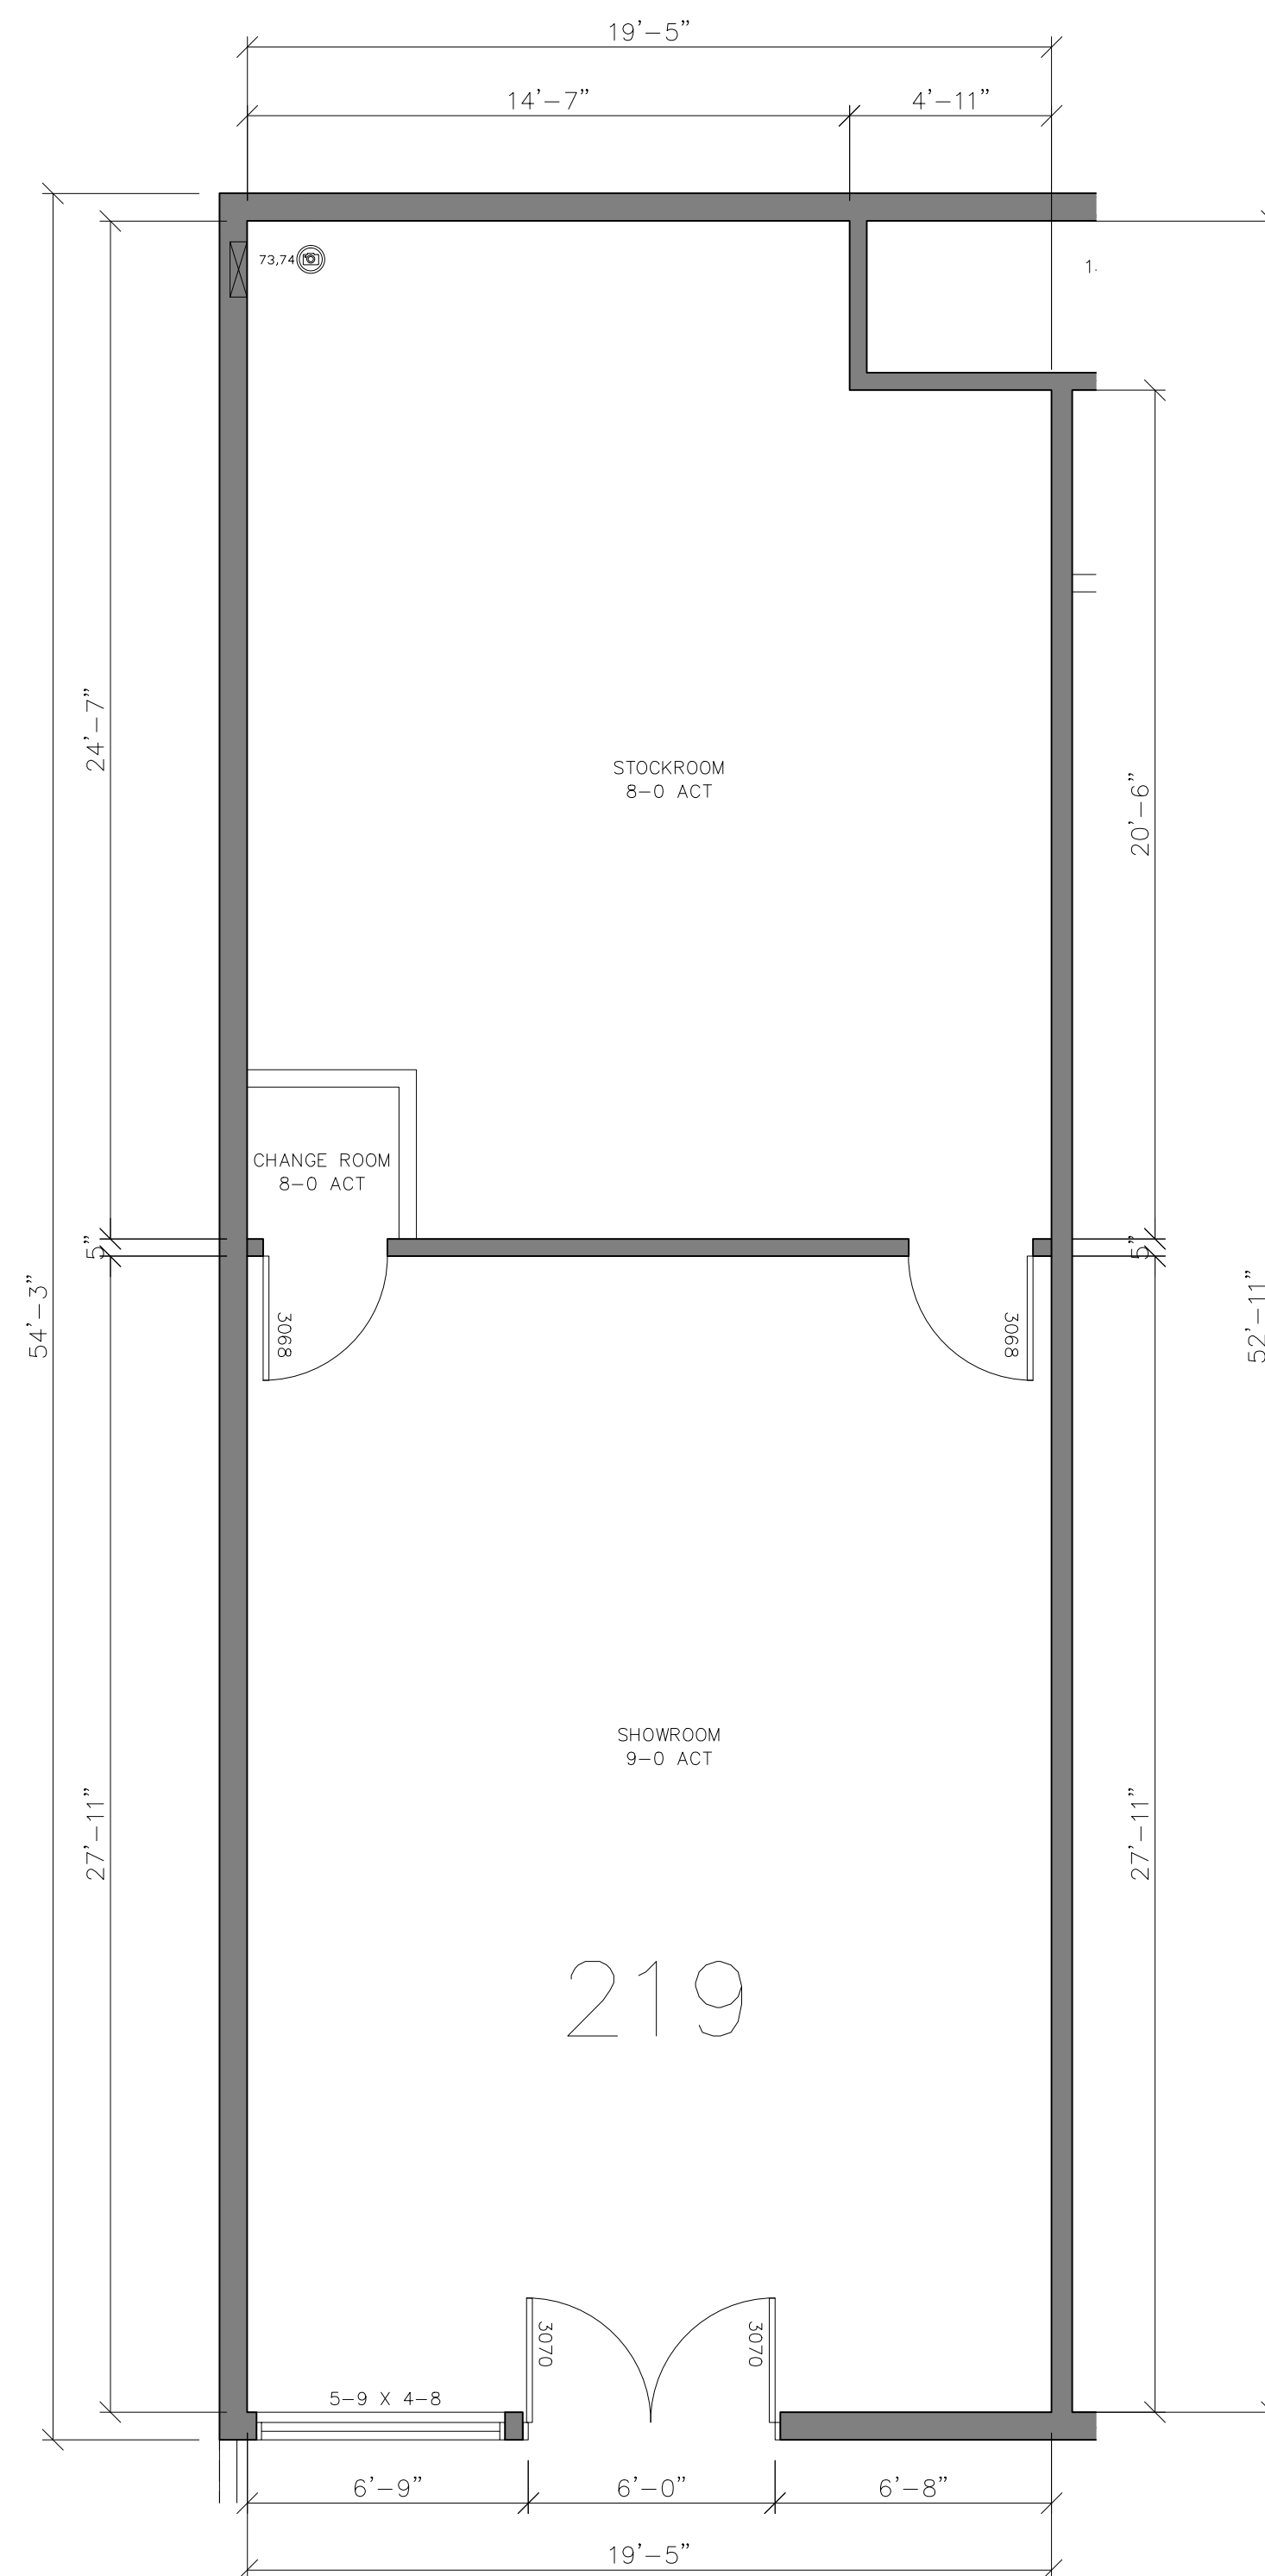

219 – FLOOR PLAN & RCP

SCALE: $1/4" = 1'-0"$

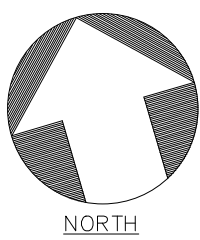

1	REVISION
NO.	ISSUES REVISIONS
DATE	
SHEET TITLE	
219 FLOORPLAN &RCP	
HL	PROJECT MANAGER
HL	PROJECT DIRECTOR
	PROJECT NUMBER
1/4"=1'-0"	SCALE
MM	DRAWN BY
	SHEET NUMBER

AB-32



ARCHITECTURAL AS BUILT
CALA CENTER
SUNNYVALE, CA 94087

1	REVISION	
NO.	ISSUES REVISIONS	DATE
		SHEET TITLE
217 FLOORPLAN &RCP		
HL		PROJECT MANAGER
HL		PROJECT DIRECTOR
		PROJECT NUMBER
1/4"=1'-0"		SCALE
MM		DRAWN BY
		SHEET NUMBER
AB-33		

ARCHITECTURAL AS BUILT
CALA CENTER
SUNNYVALE, CA 94087

[illegible]

1	REVISION	
NO.	ISSUES REVISIONS	DATE

SHEET TITLE

215 FLOORPLAN &RCP

HI	PROJECT MANAGER
----	-----------------


HL	PROJECT DIRECTOR
----	------------------

PROJECT NUMBER

1/4"=1'-0" SCALE


MM	DRAWN BY
----	----------

AB-34

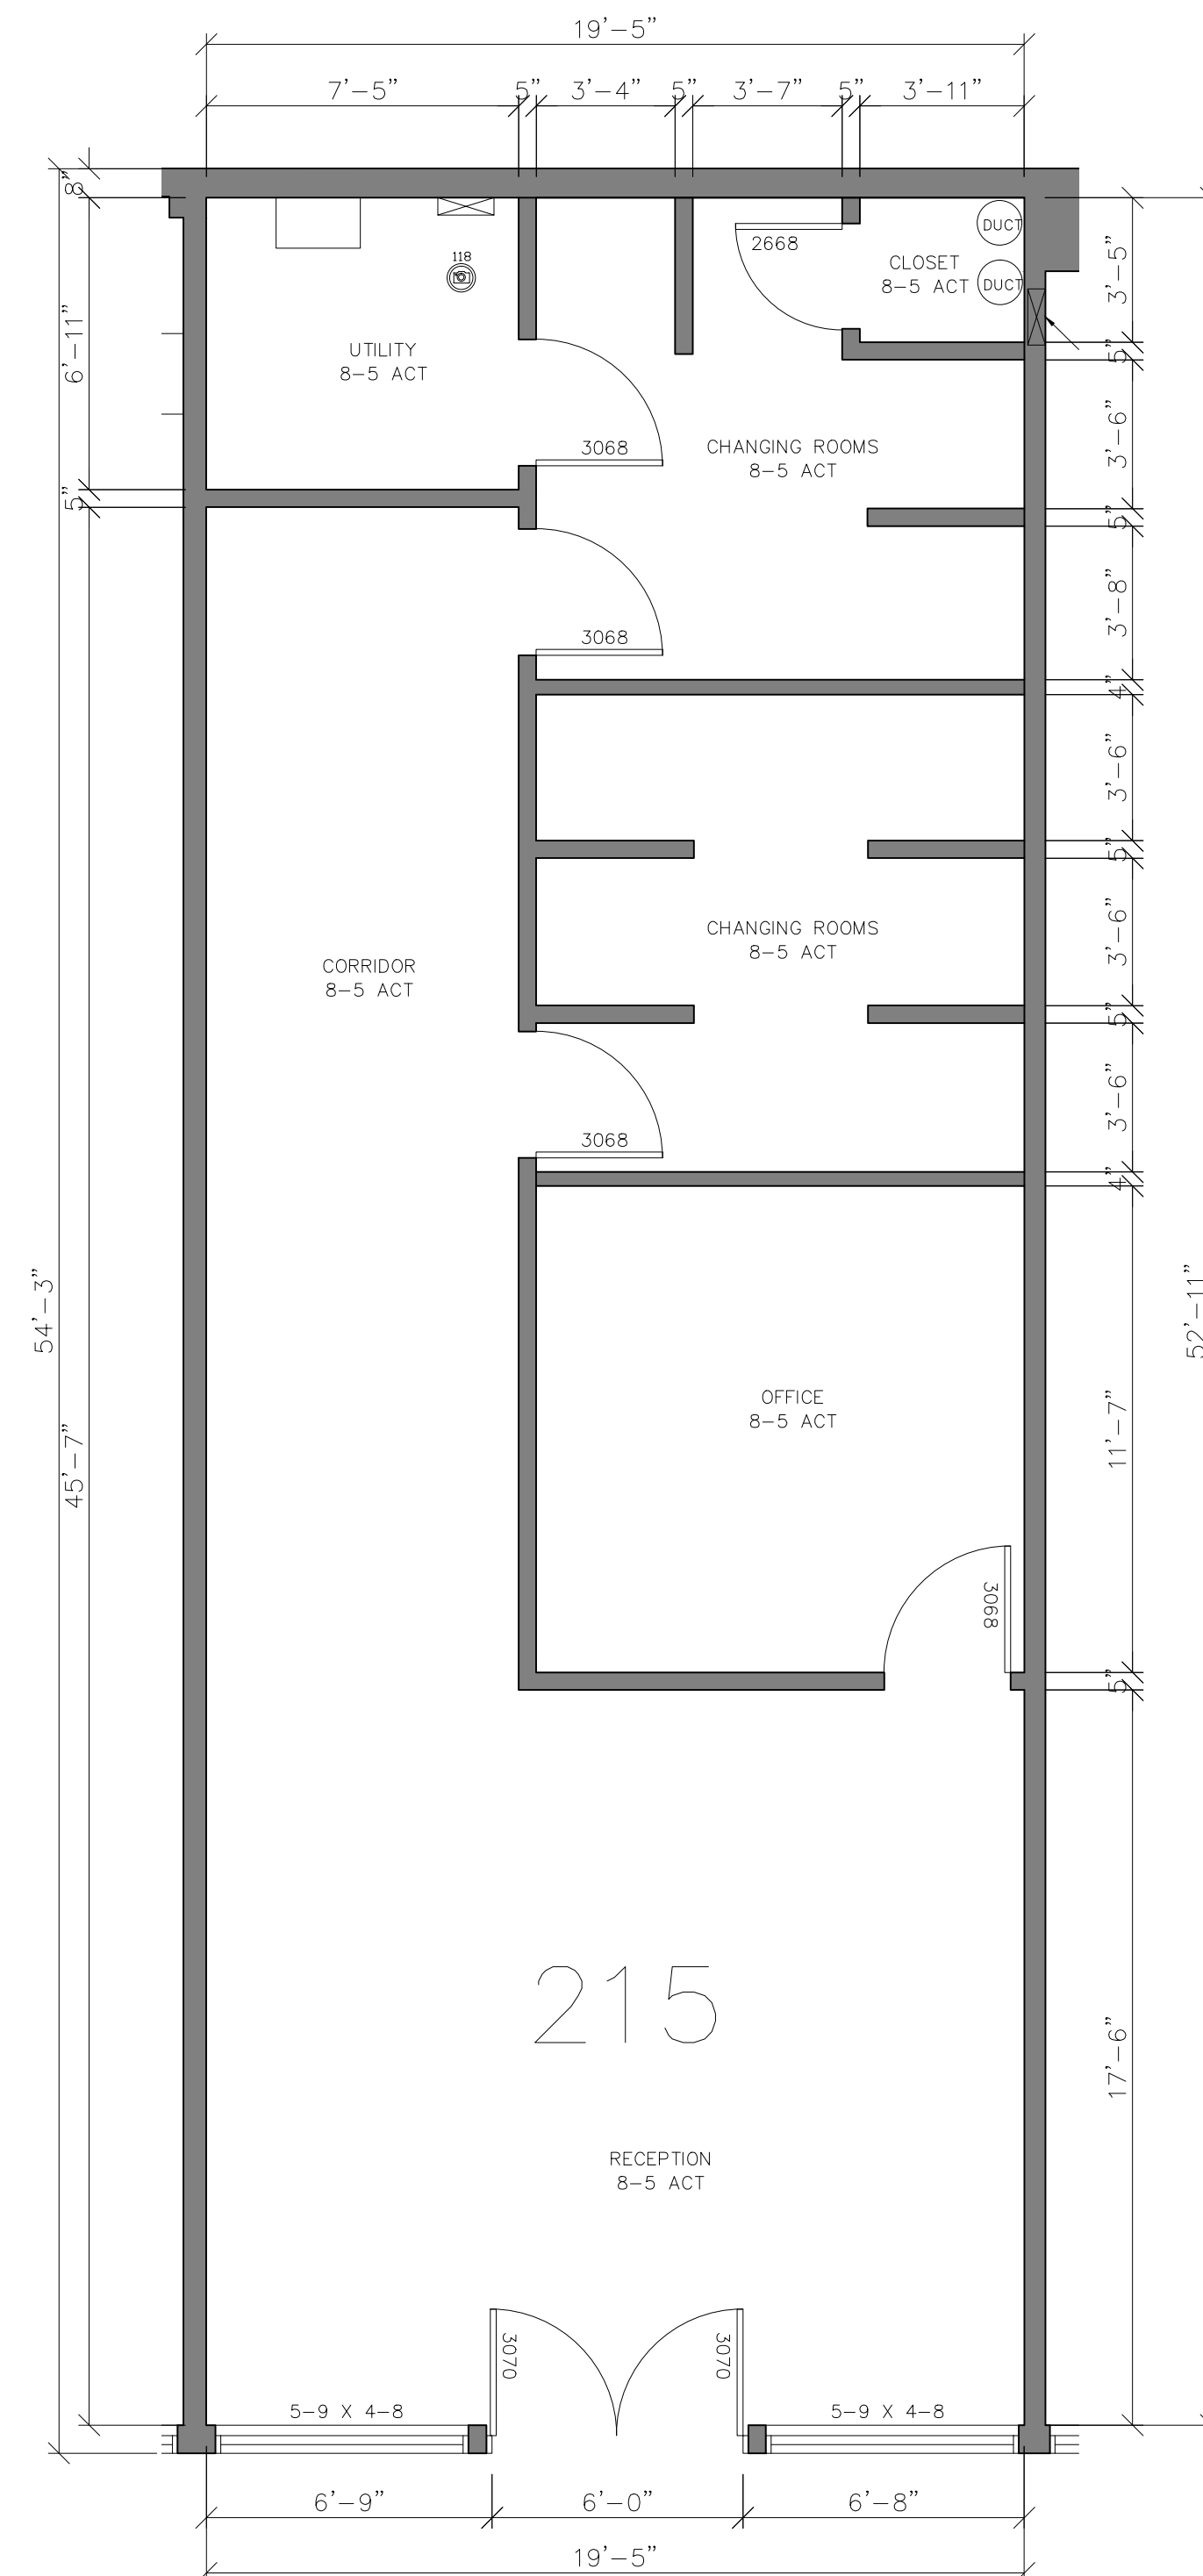

215 – FLOOR PLAN & RCP

SCALE: $1/4" = 1'-0"$

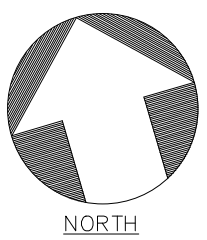



CALA CENTER

SUNNYVALE, CA 94087



NORTH

AB-35

ARCHITECTURAL AS BUILT
CALA CENTER
SUNNYVALE, CA 94087

[illegible]

1	REVISION	
NO.	ISSUES REVISIONS	DATE

SHEET TITLE

211
FLOORPLAN
&RCP

HL	PROJECT MANAGER
----	-----------------

HL	PROJECT DIRECTOR
----	------------------


PROJECT NUMBER

1/4"=1'-0" SCALE

MM	DRAWN BY
----	----------


SHEET NUMBER

AB-36

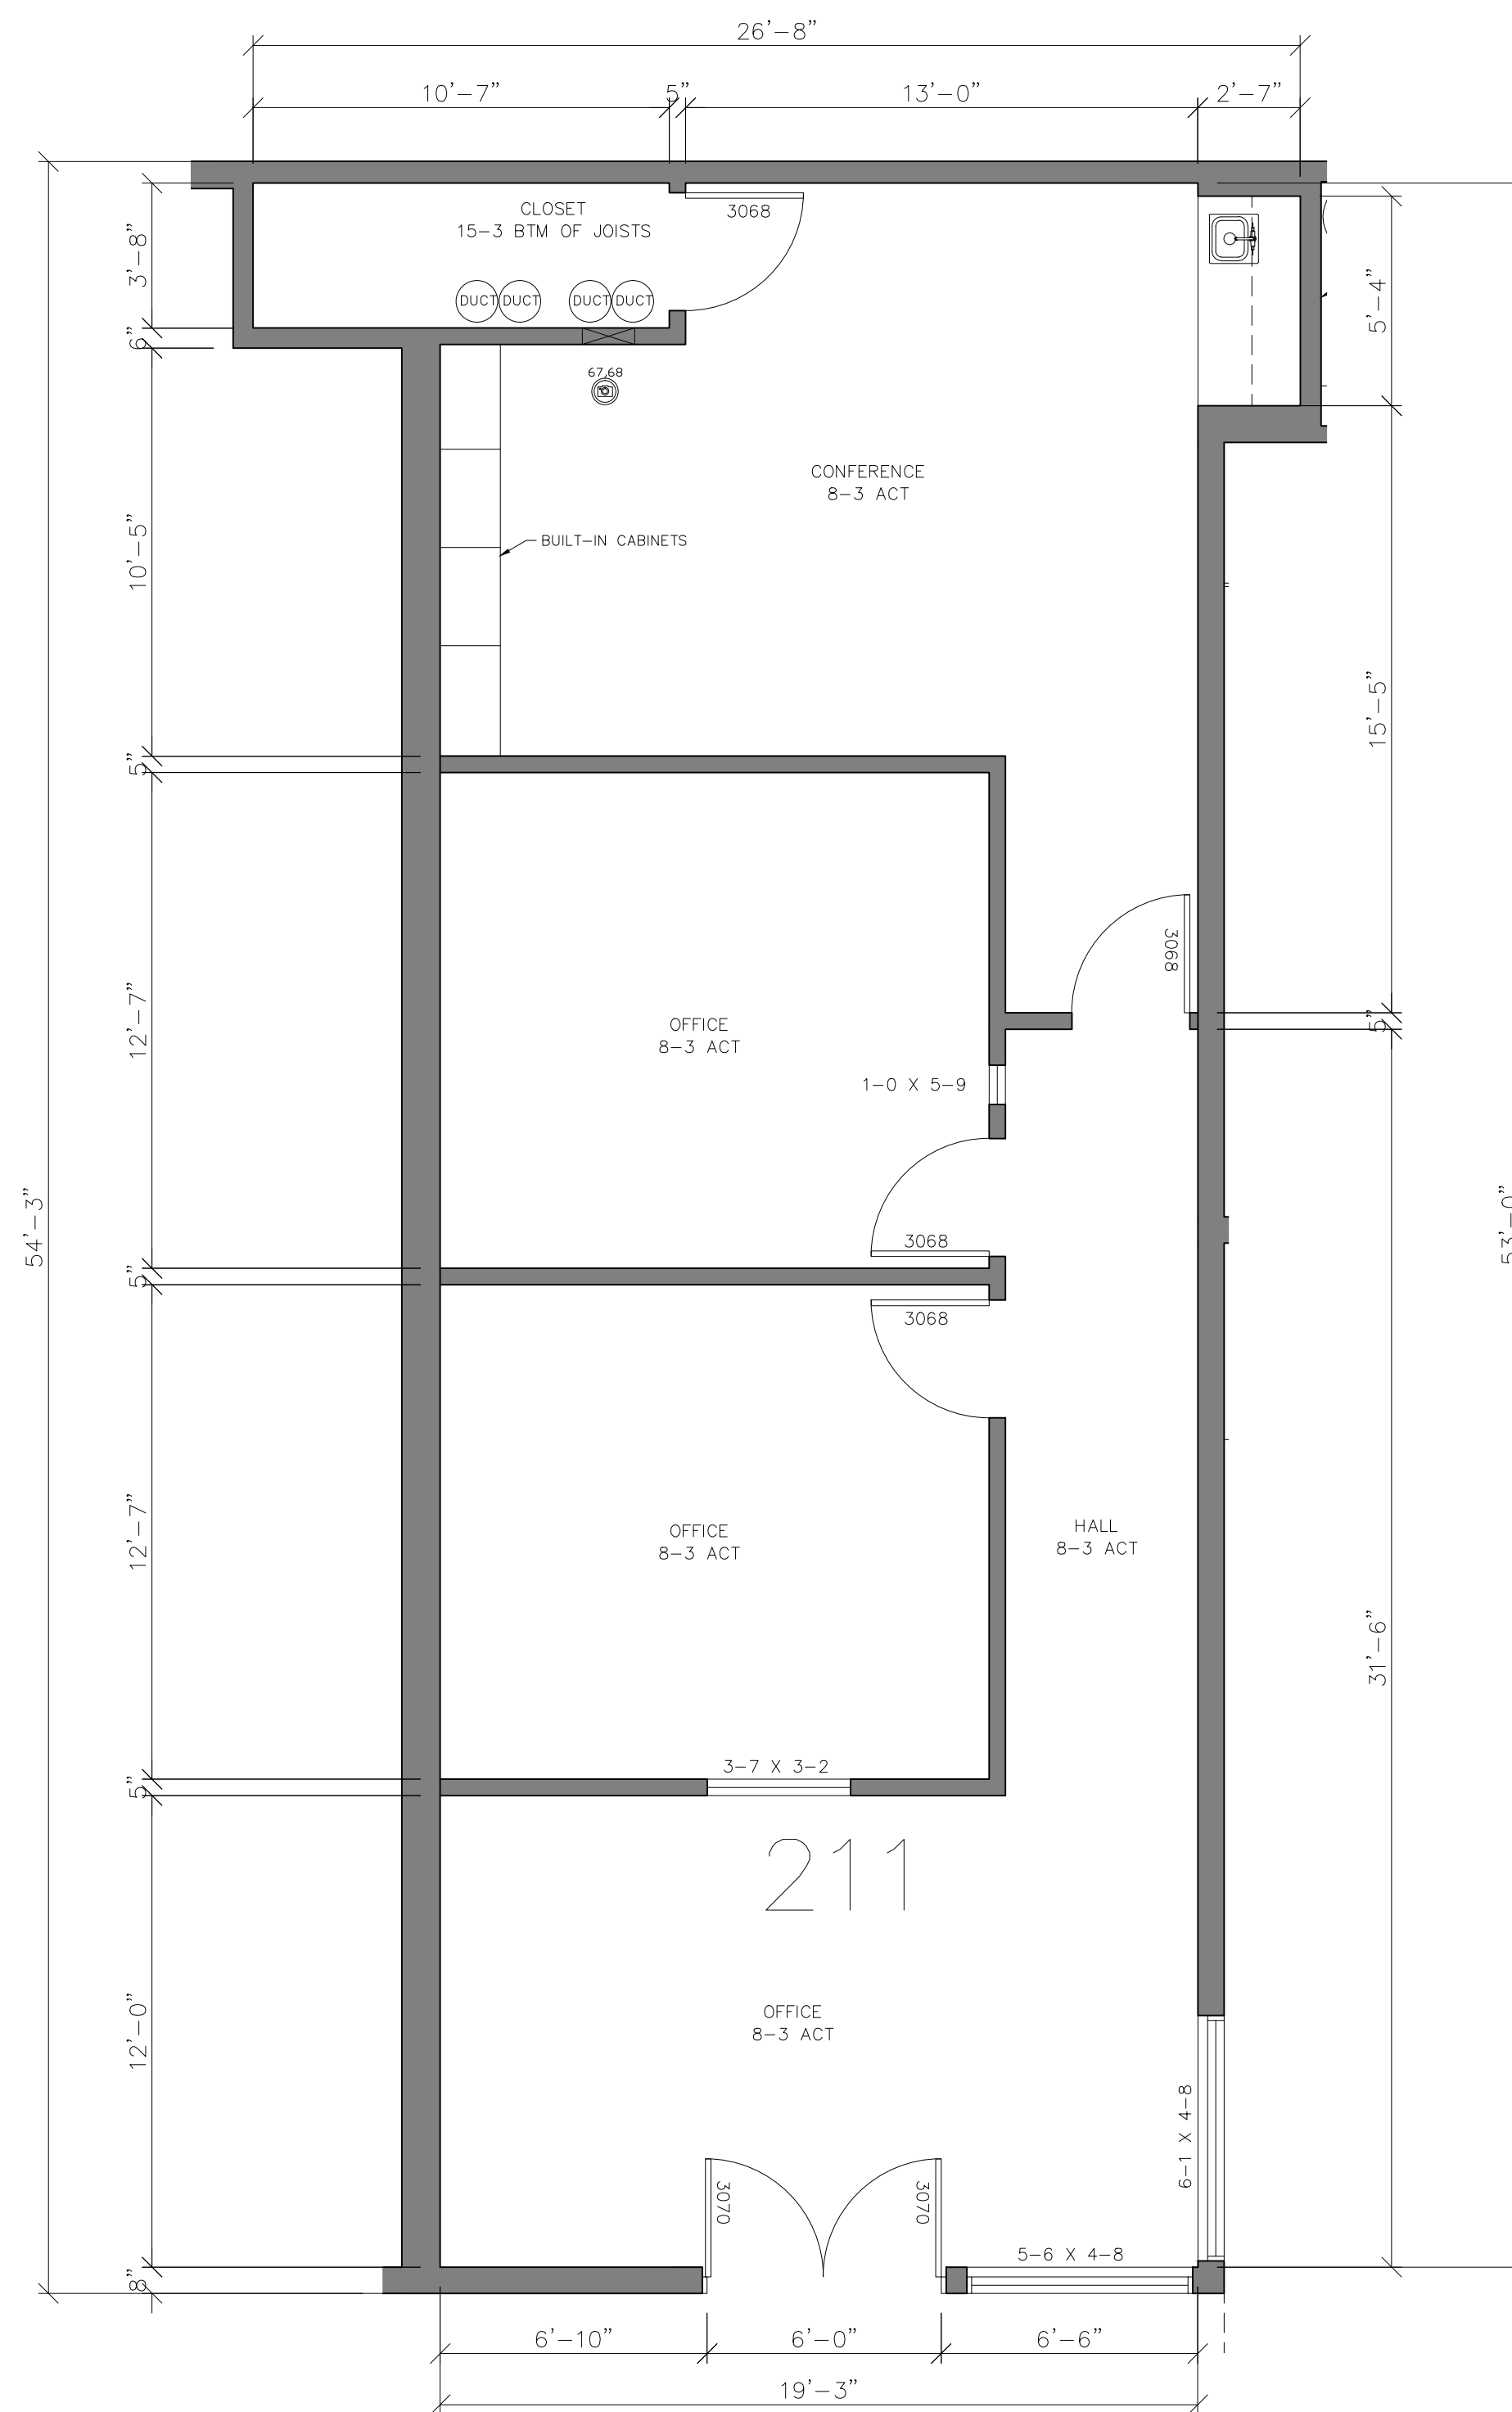




211 – FLOOR PLAN & RCP

SCALE: $1/4" = 1'-0"$

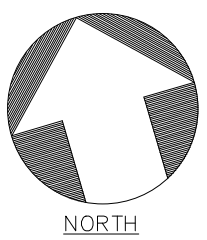



AB-37

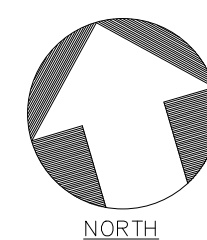  

ARCHITECTURAL AS BUILT

CALA CENTER
SUNNYVALE, CA 94087

[illegible]


1	REVISION	
NO.	ISSUES REVISIONS	DATE

SHEET TITLE

**109
FLOORPLAN
&RCP**


HL	PROJECT MANAGER
HL	PROJECT DIRECTOR
	PROJECT NUMBER
1/4"=1'-0"	SCALE
MM	DRAWN BY


AB-38

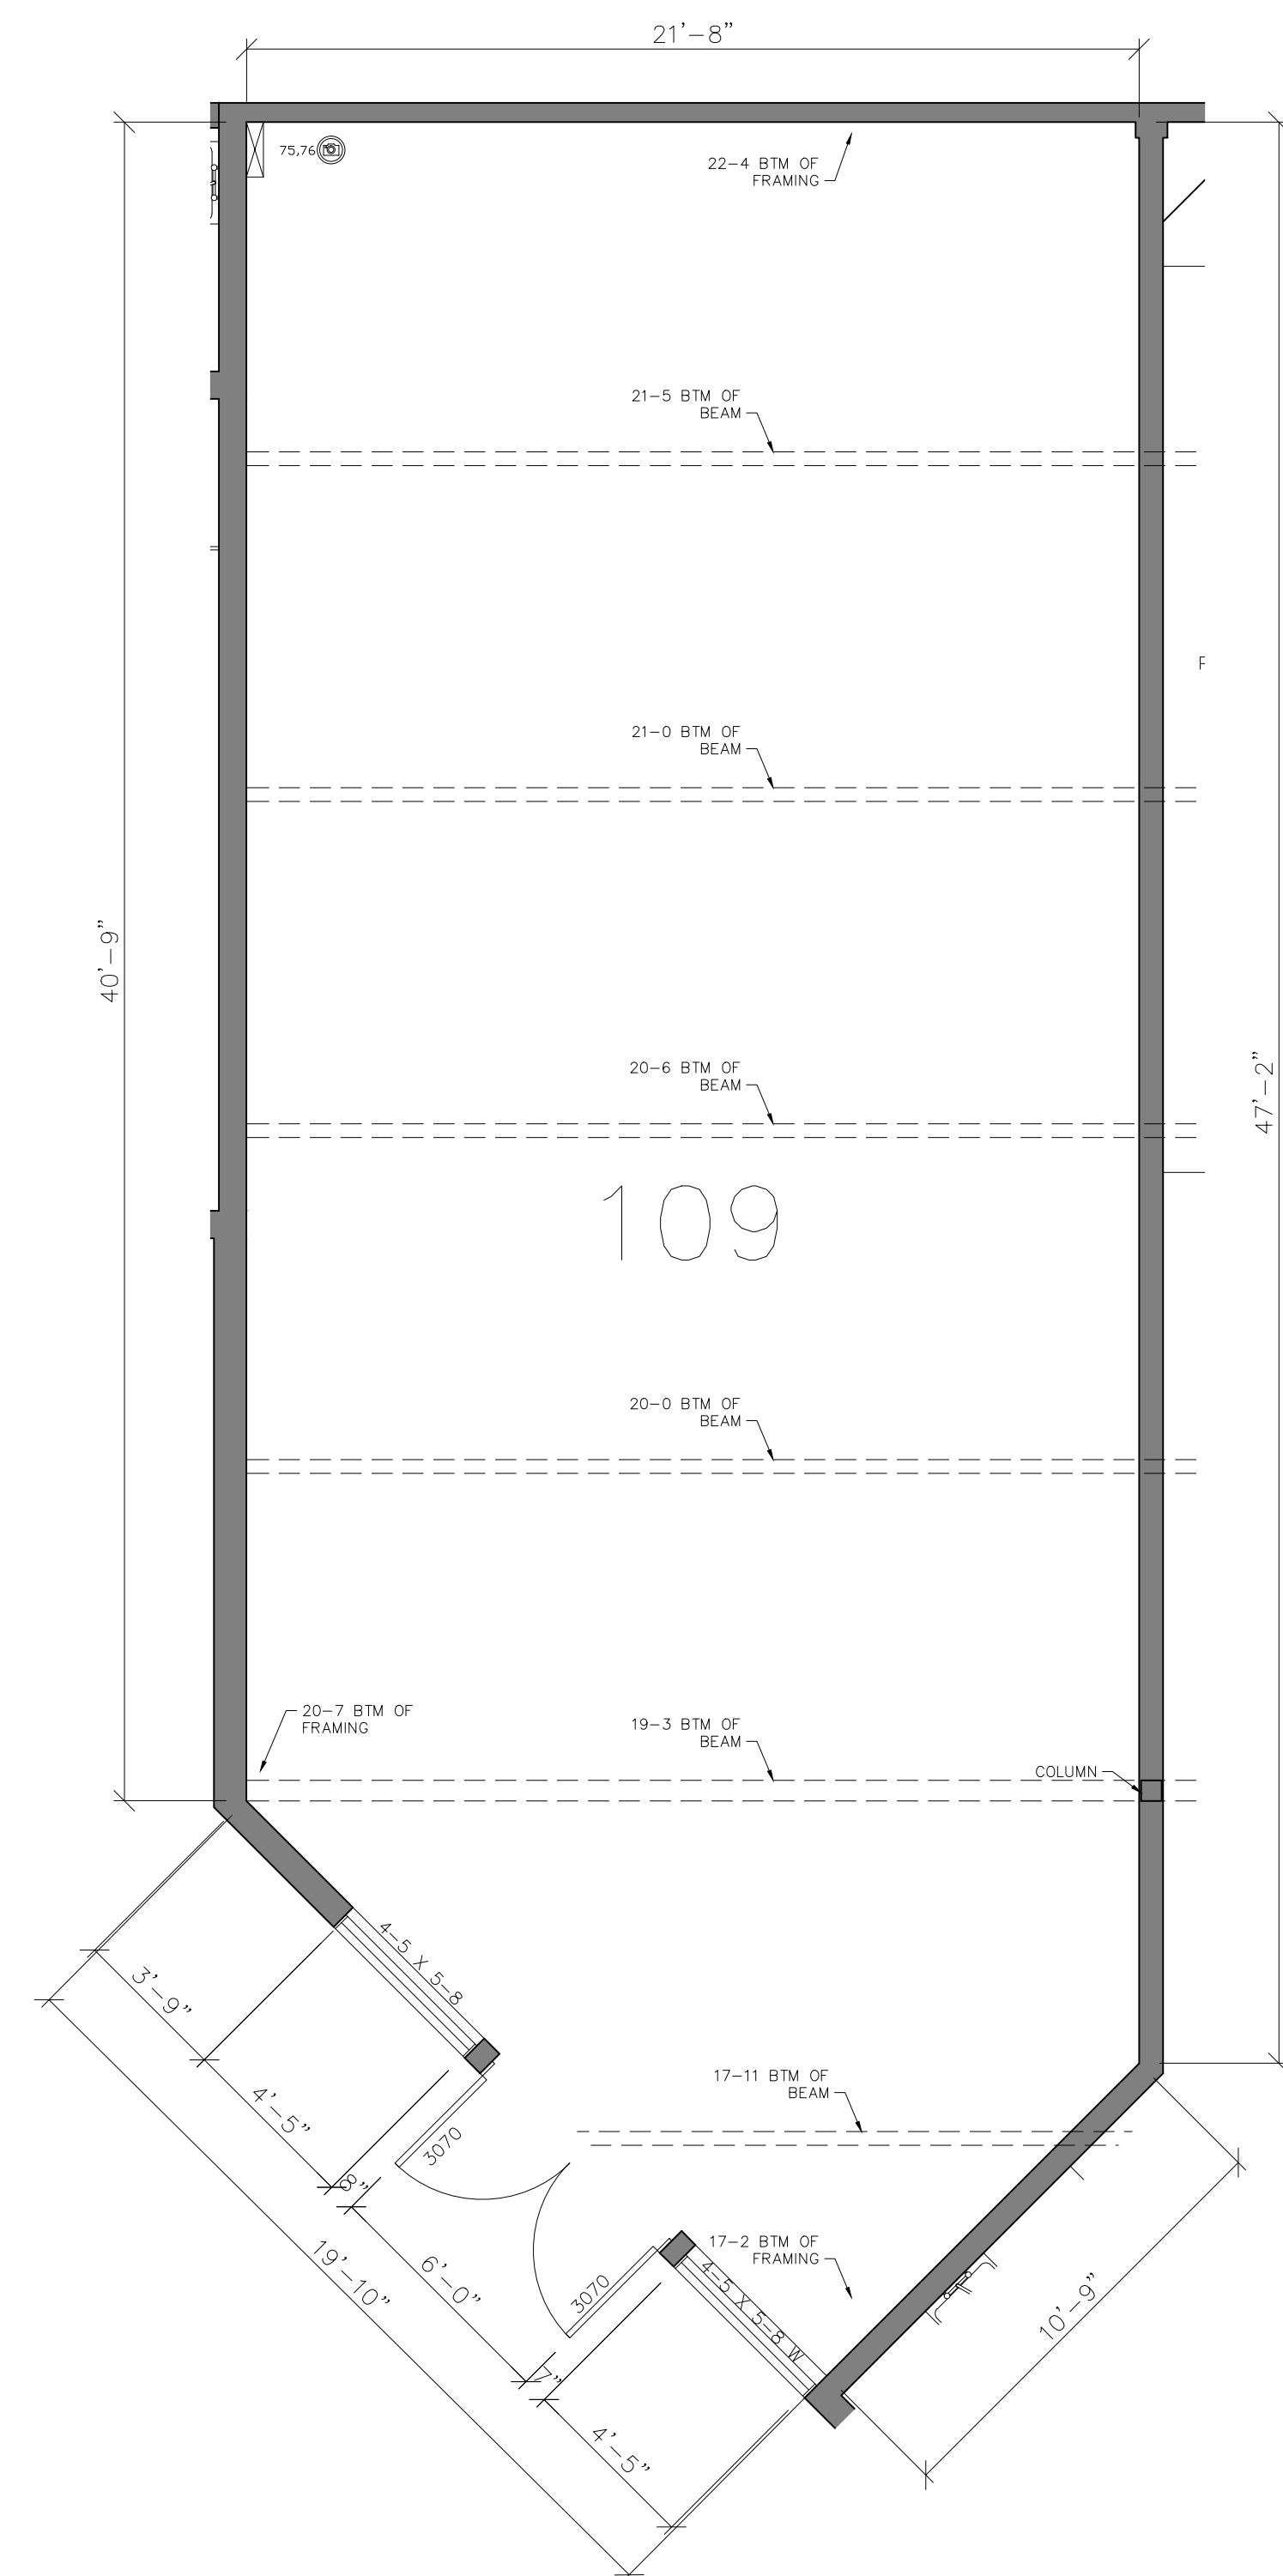

109 – FLOOR PLAN & RCP

SCALE: $1/4" = 1'-0"$

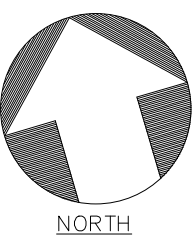

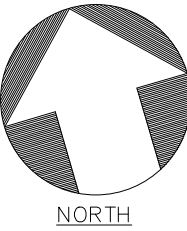



SCALE: $1/4" = 1'-0"$

SUNNYVALE, CA 94087

HL	PROJECT MANAGER
HL	PROJECT DIRECTOR
	PROJECT NUMBER
1/4"=1'-0"	SCALE
MM	DRAWN BY
	SHEET NUMBER

ARCHITECTURAL AS BUILT


CALA CENTER
SUNNYVALE, CA 94087

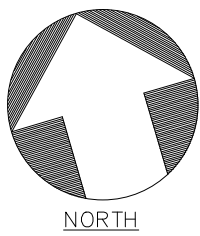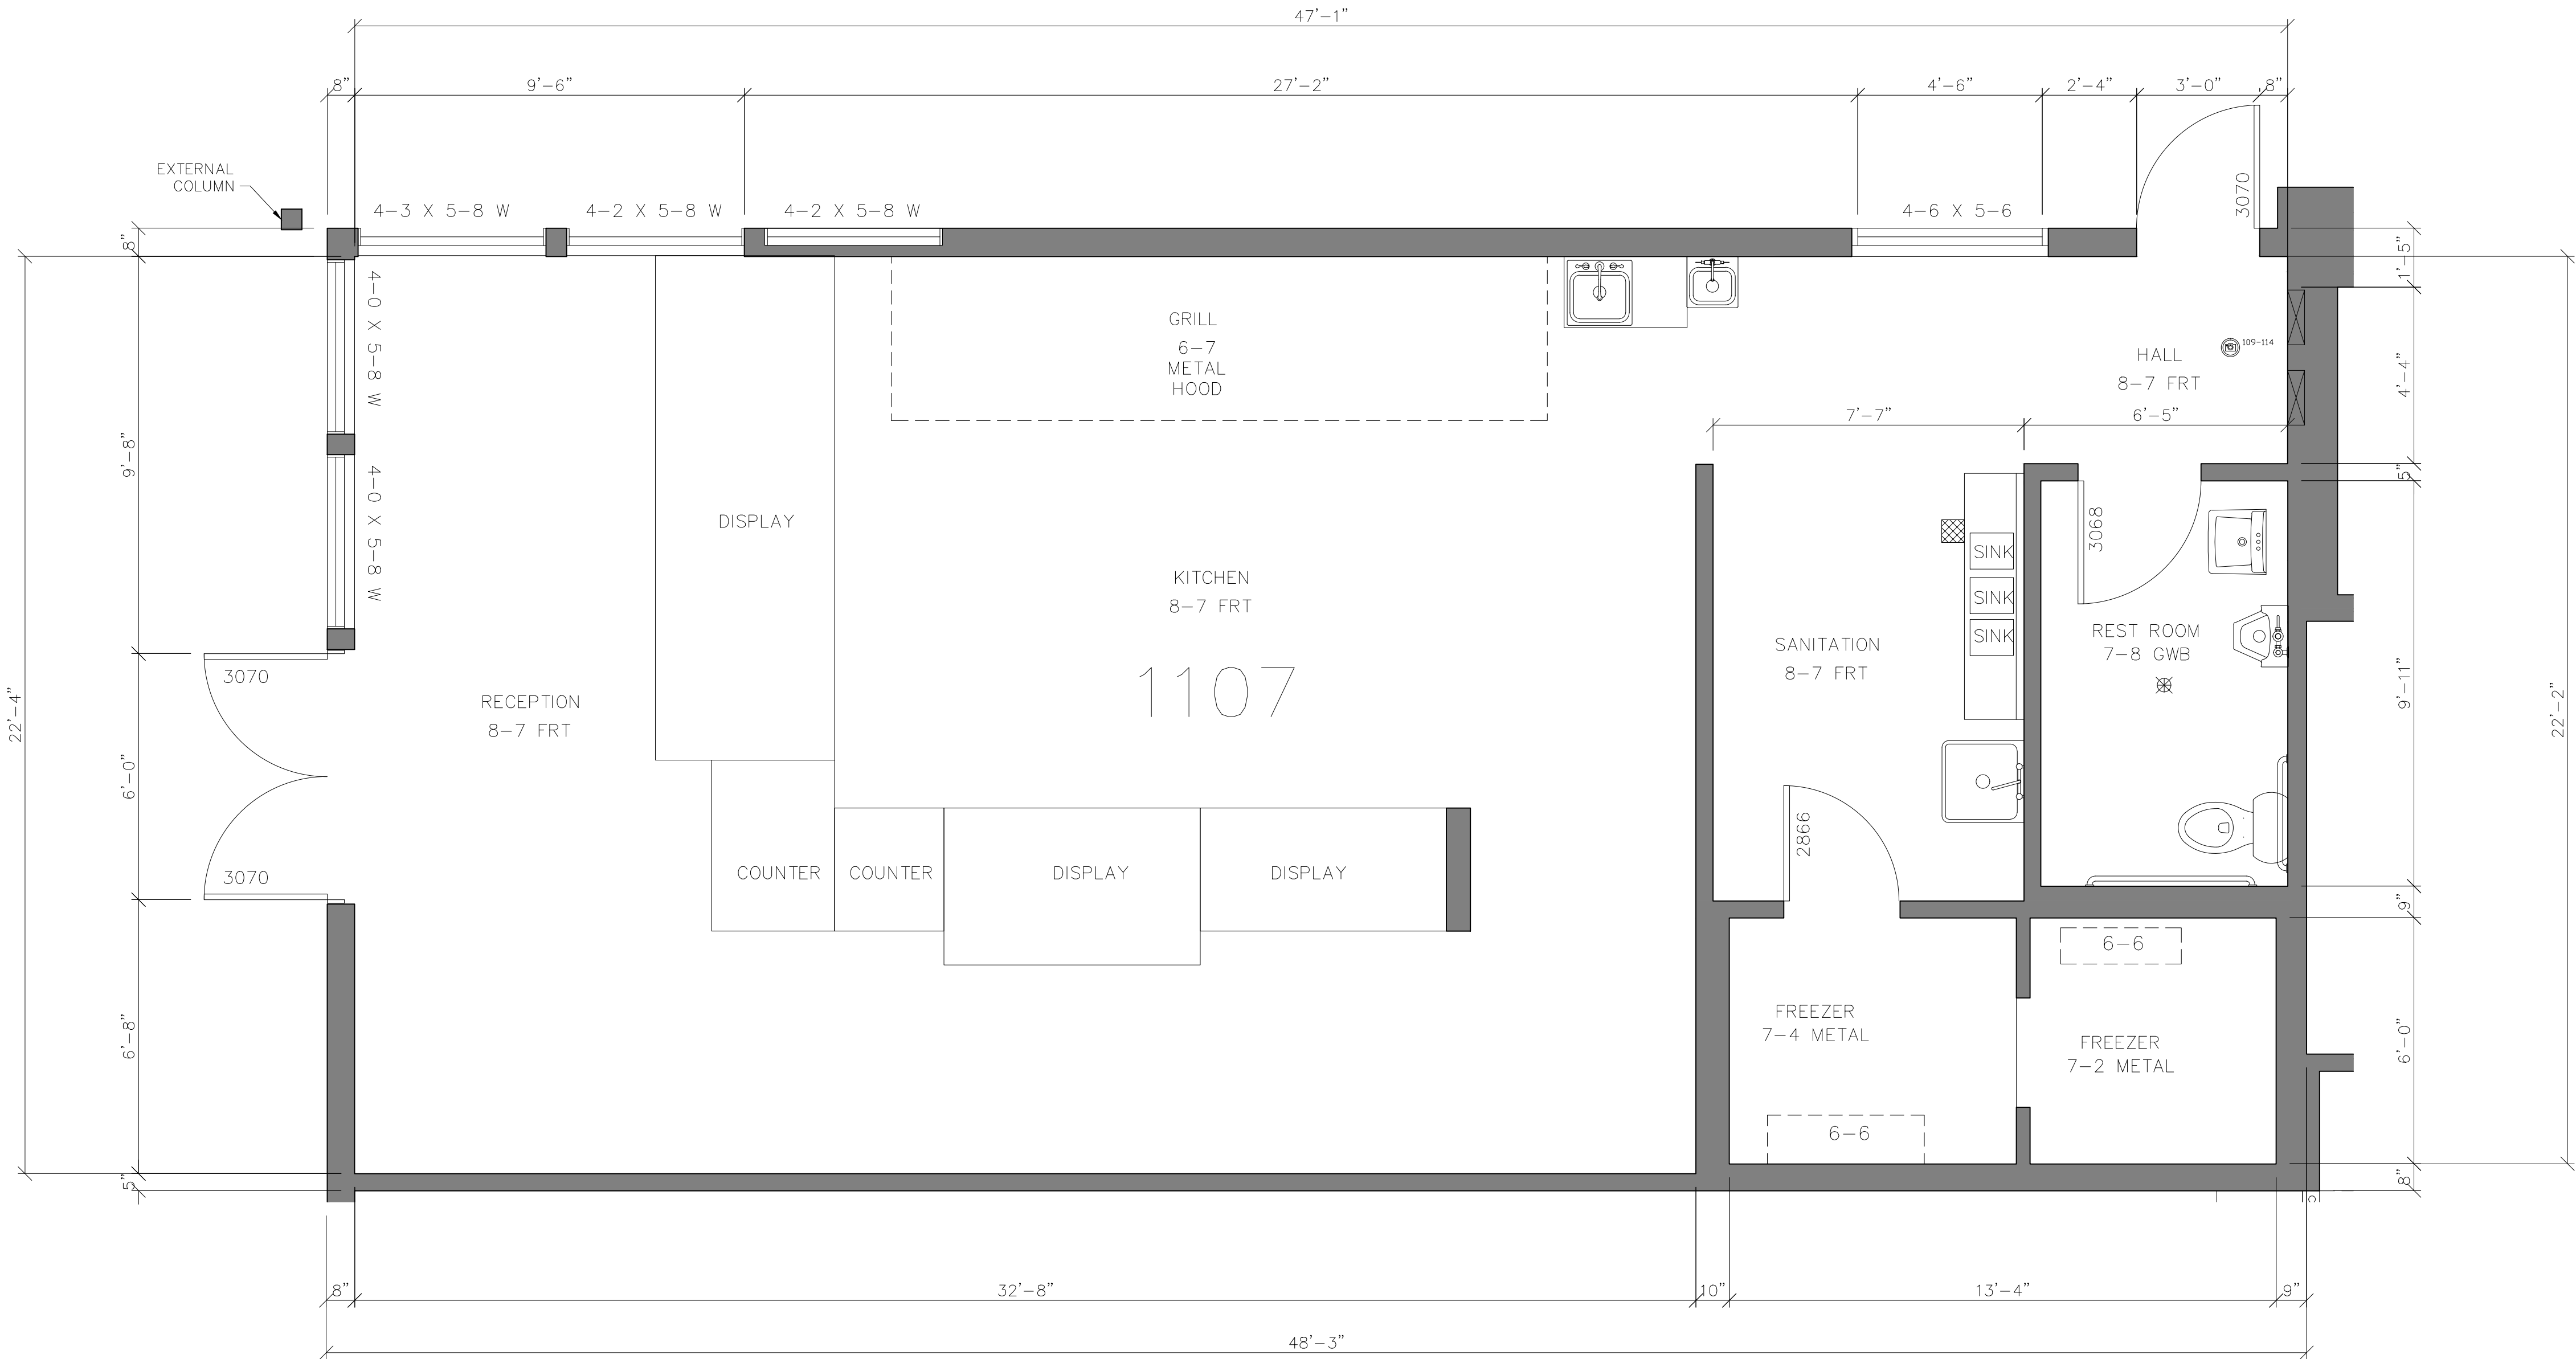

1107 – FLOOR PLAN & RCP
SCALE: 3/8" = 1'-0"

1	REVISION	
NO.	ISSUES REVISIONS	DATE
SHEET TITLE		
1107 FLOORPLAN &RCP		
HL	PROJECT MANAGER	
HL	PROJECT DIRECTOR	
	PROJECT NUMBER	
	SCALE	
MM	DRAWN BY	
SHEET NUMBER		

AB-40

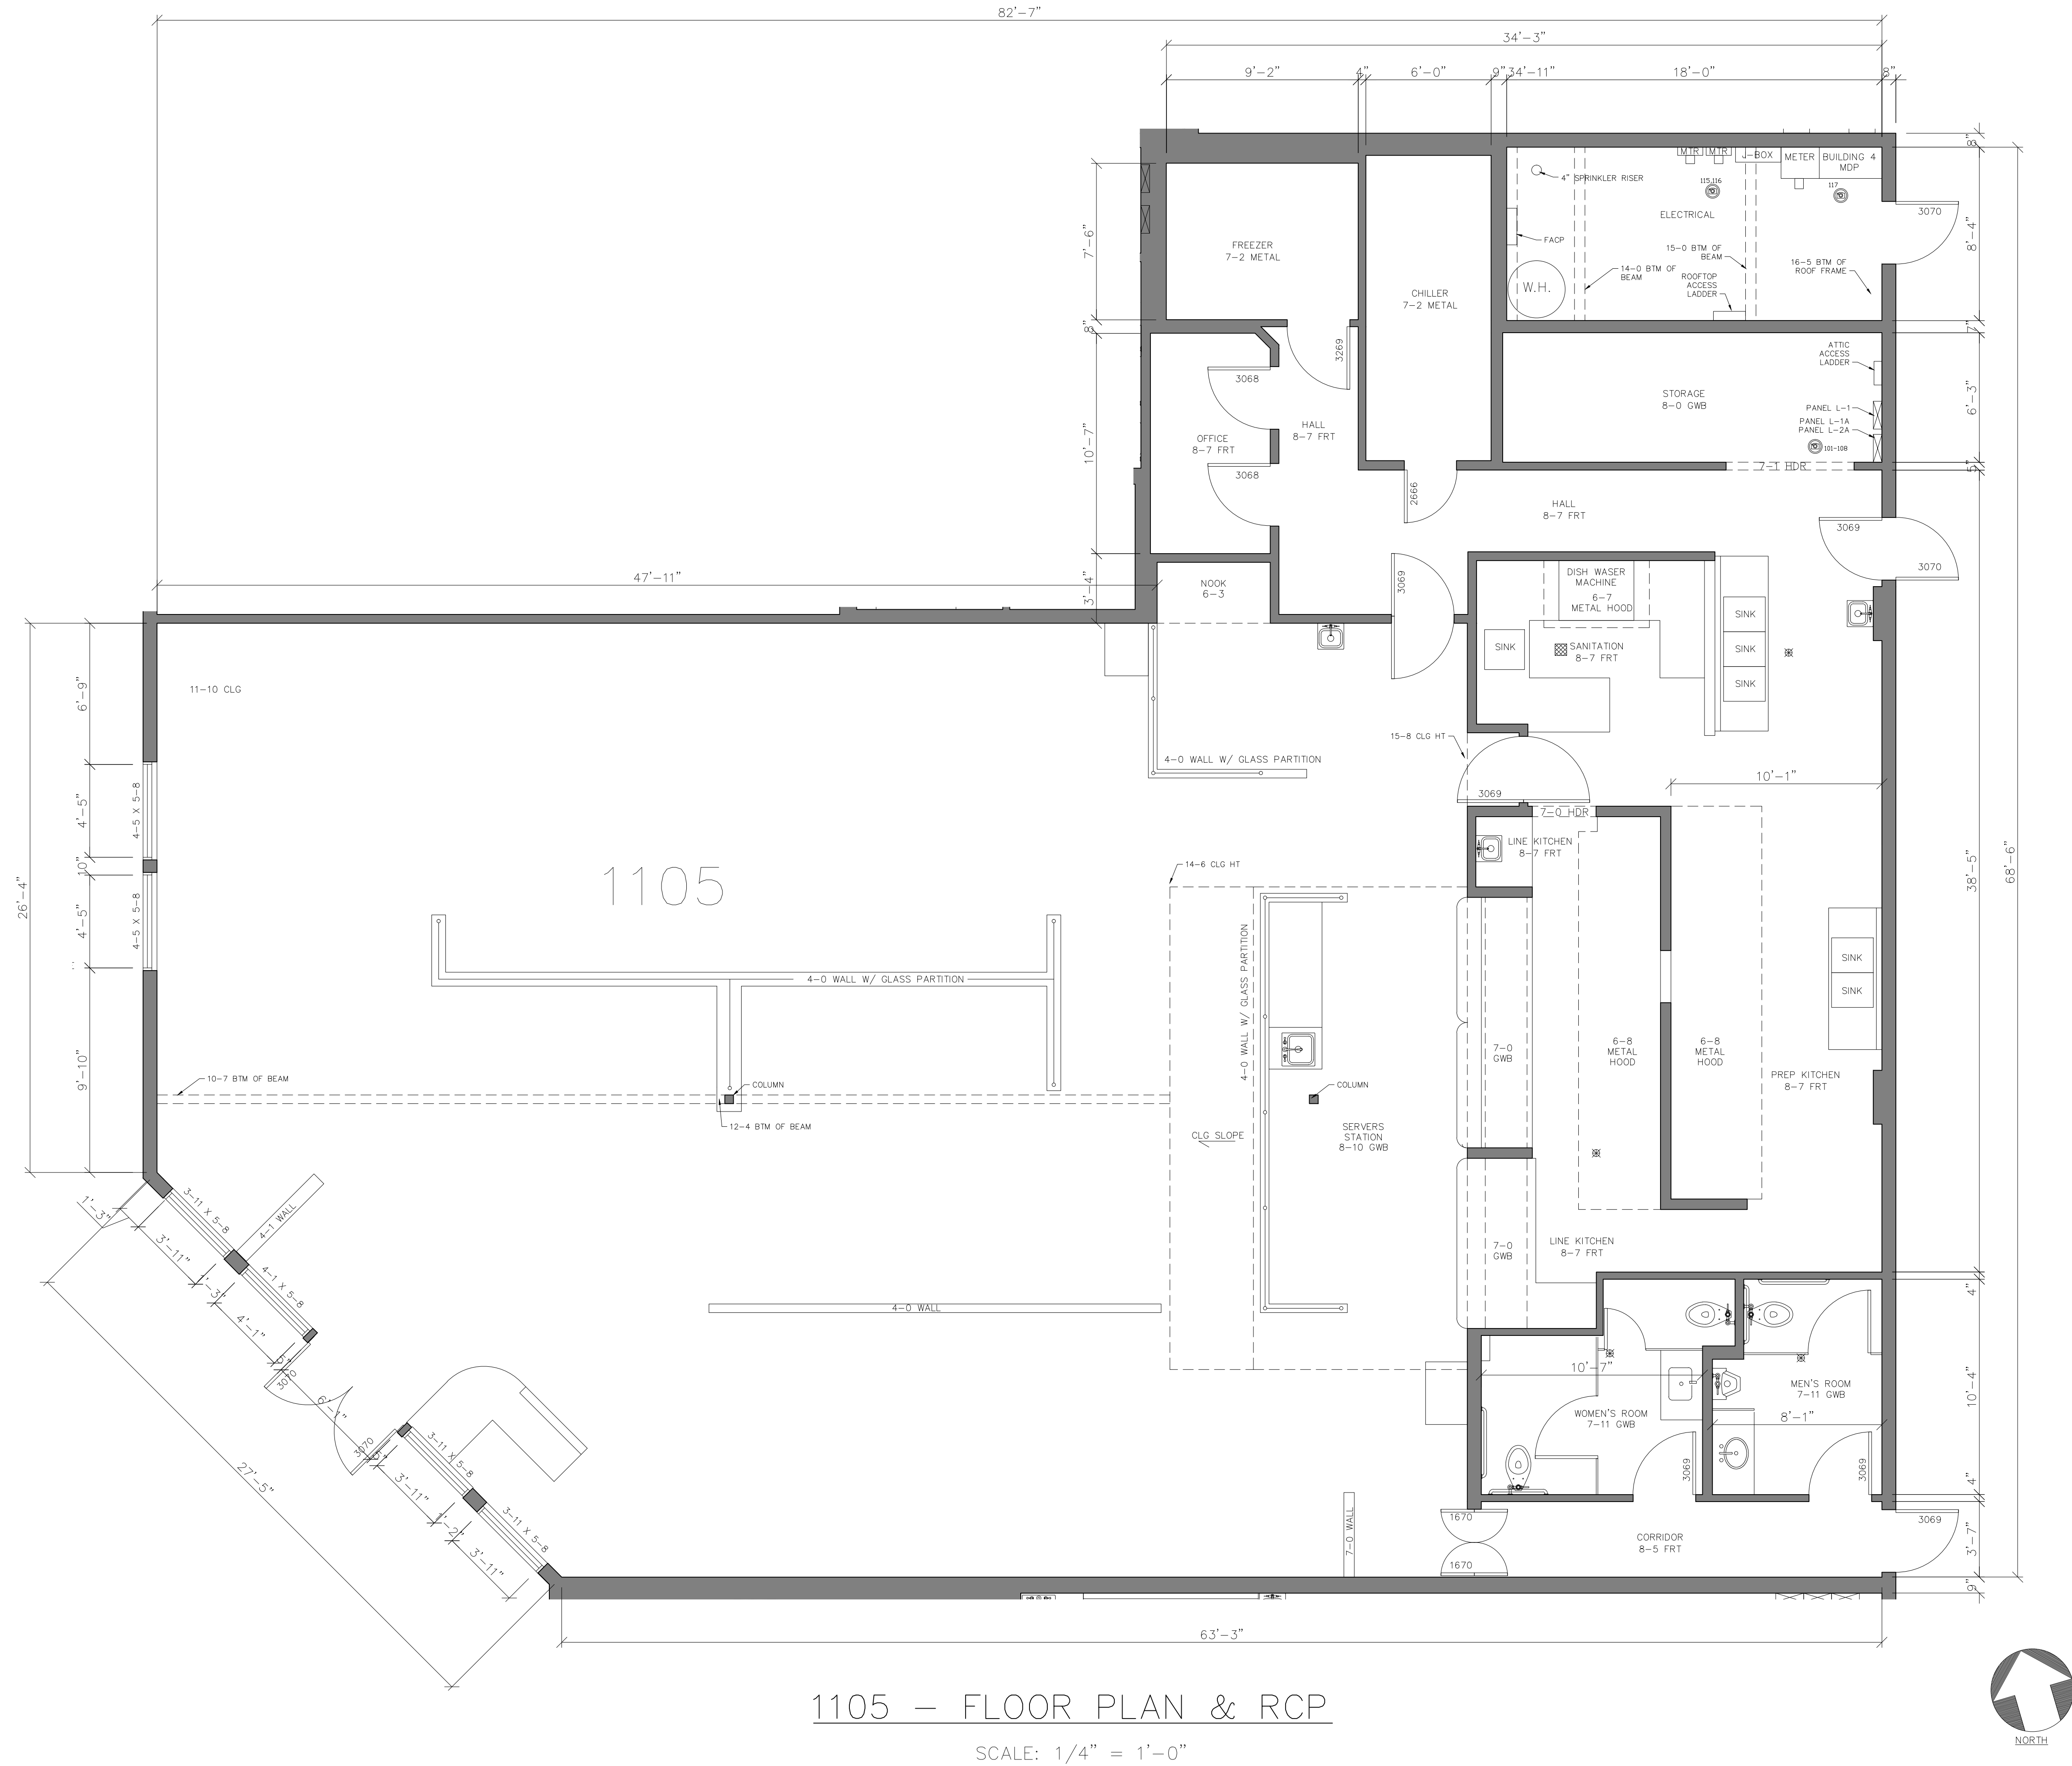

1105 — FLOOR PLAN & RCP

SCALE: 1/4" = 1'-0"

ARCHITECTURAL AS BUILT

ALA CENTER
SUNNYVALE, CA 94087

REVISION		
NO.	ISSUES REVISIONS	DATE
1		
SHEET TITLE		
1105 FLOORPLAN & RCP		
HL	PROJECT MANAGER	
HL	PROJECT DIRECTOR	
	PROJECT NUMBER	
	SCALE	
1/4"=1'-0"		
MM	DRAWN BY	
	SHEET NUMBER	

ARCHITECTURAL AS BUILT

CALA CENTER
SUNNYVALE, CA 94087

[illegible]


1	REVISION	
NO.	ISSUES REVISIONS	DATE

ET TITLE

1101 FLOORPLAN &RCP

HL	PROJECT MANAGER
HL	PROJECT DIRECTOR
	PROJECT NUMBER
1/4"=1'-0"	SCALE
MM	DRAWN BY
	SHEET NUMBER

AB-42

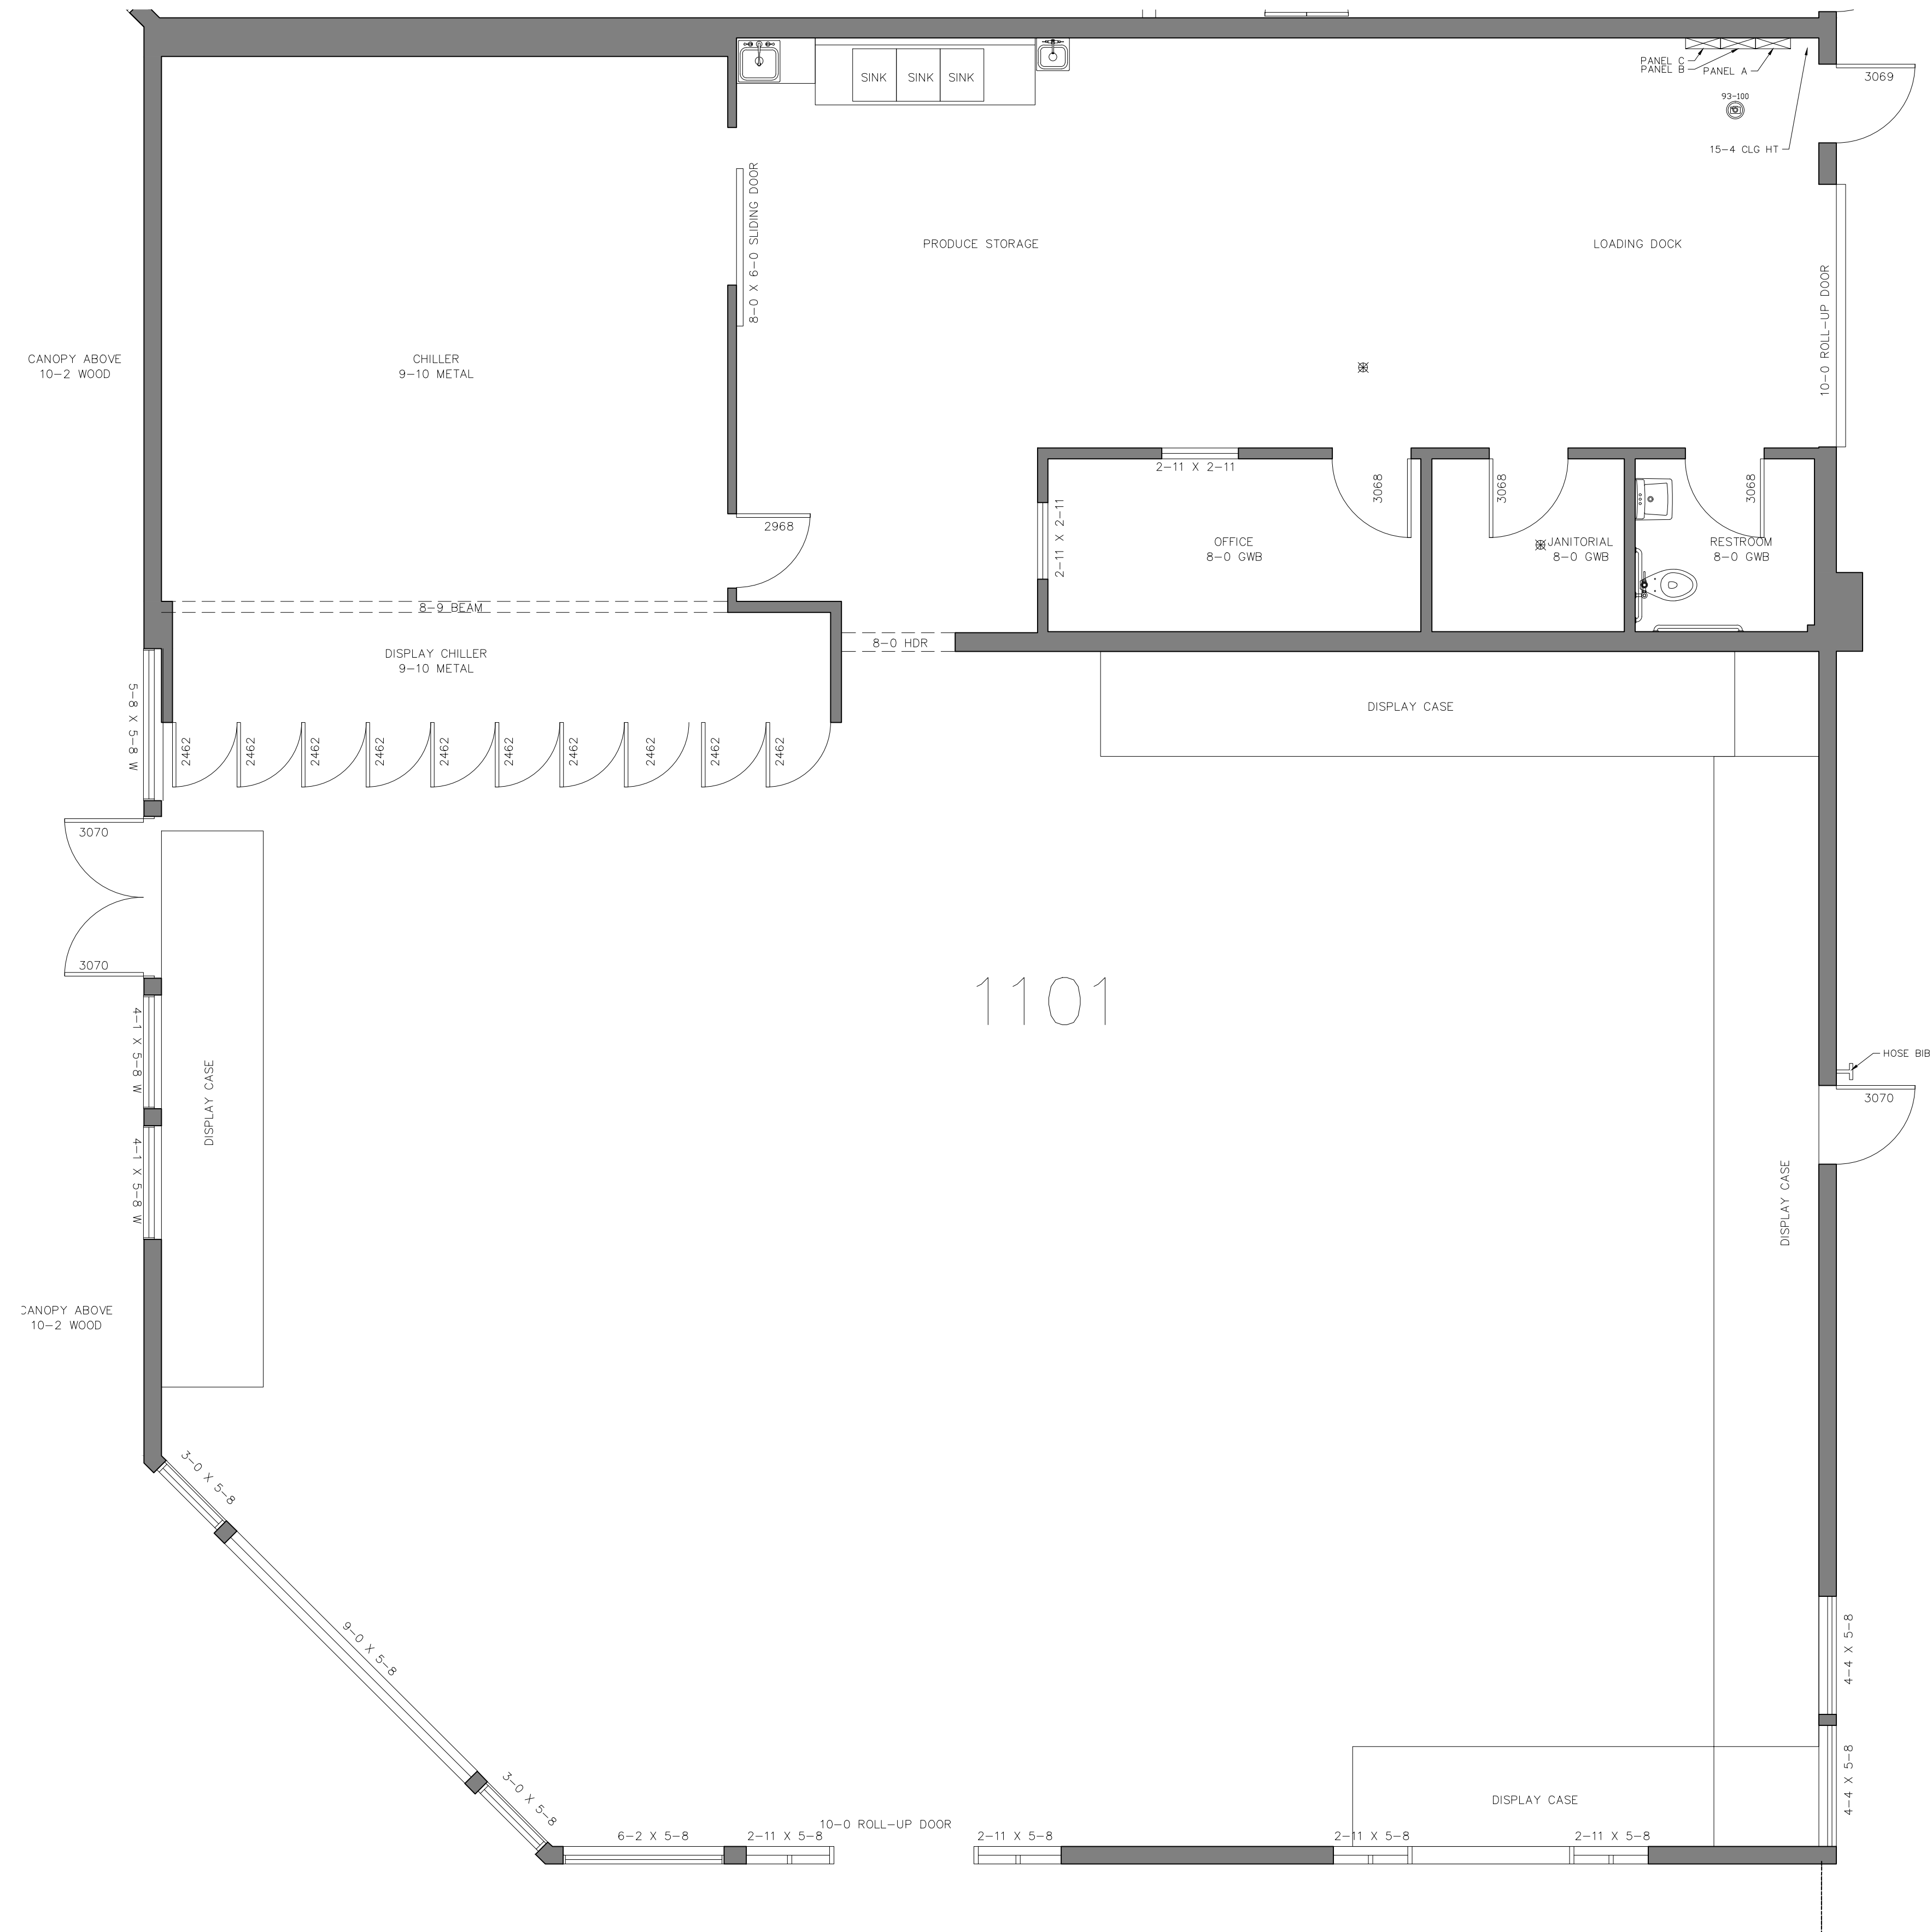

1101 – FLOOR PLAN & RCP

SCALE: $1/4" = 1'-0"$

