

NORFOLK, VA 23504




100% SUBMITTAL

DRAWING INDEX

C-1	COVER SHEET	AB-11	FLOOR 7 UNITS
SL	SYMBOLS LEGEND	AB-12	FLOOR 7 UNITS
AB-1	FLOOR 2 UNITS	AB-13	FLOOR 8 UNITS
AB-2	FLOOR 2 UNITS	AB-14	FLOOR 8 UNITS
AB-3	FLOOR 3 UNITS	AB-15	FLOOR 9 UNITS
AB-4	FLOOR 3 UNITS	AB-16	FLOOR 9 UNITS
AB-5	FLOOR 4 UNITS	AB-17	FLOOR 10 UNITS
AB-6	FLOOR 4 UNITS	AB-18	FLOOR 10 UNITS
AB-7	FLOOR 5 UNITS	AB-19	FLOOR 11 UNITS
AB-8	FLOOR 5 UNITS	AB-20	FLOOR 11 UNITS
AB-9	FLOOR 6 UNITS		
AB-10	FLOOR 6 UNITS		

Scope of Work:

- | | |
|--|--|
| ☒ FLOOR PLANS | CLOSETS: |
| ☒ WALLS | ☒ RCP WITH MEP |
| ☒ WINDOWS | ☒ EXPOSED PLUMBING |
| ☒ DOOR OPENING SIZES | |
| ☒ COLUMNS | RCP |
| ☒ HVAC UNITS | ☒ CEILING HEIGHTS |
| ☒ WATER HEATERS | ☒ TRANSITIONS |
| ☒ PLUMBING FIXTURES | ☒ SOFFIT HEIGHTS |
| ☒ BUILT-INS | |
| ☒ CABINET LOCATIONS | |
| ☒ APPLIANCE LOCATIONS | |
| ☒ ELEC OUTLET & SWITCH | |
| ☒ SCONCES | |

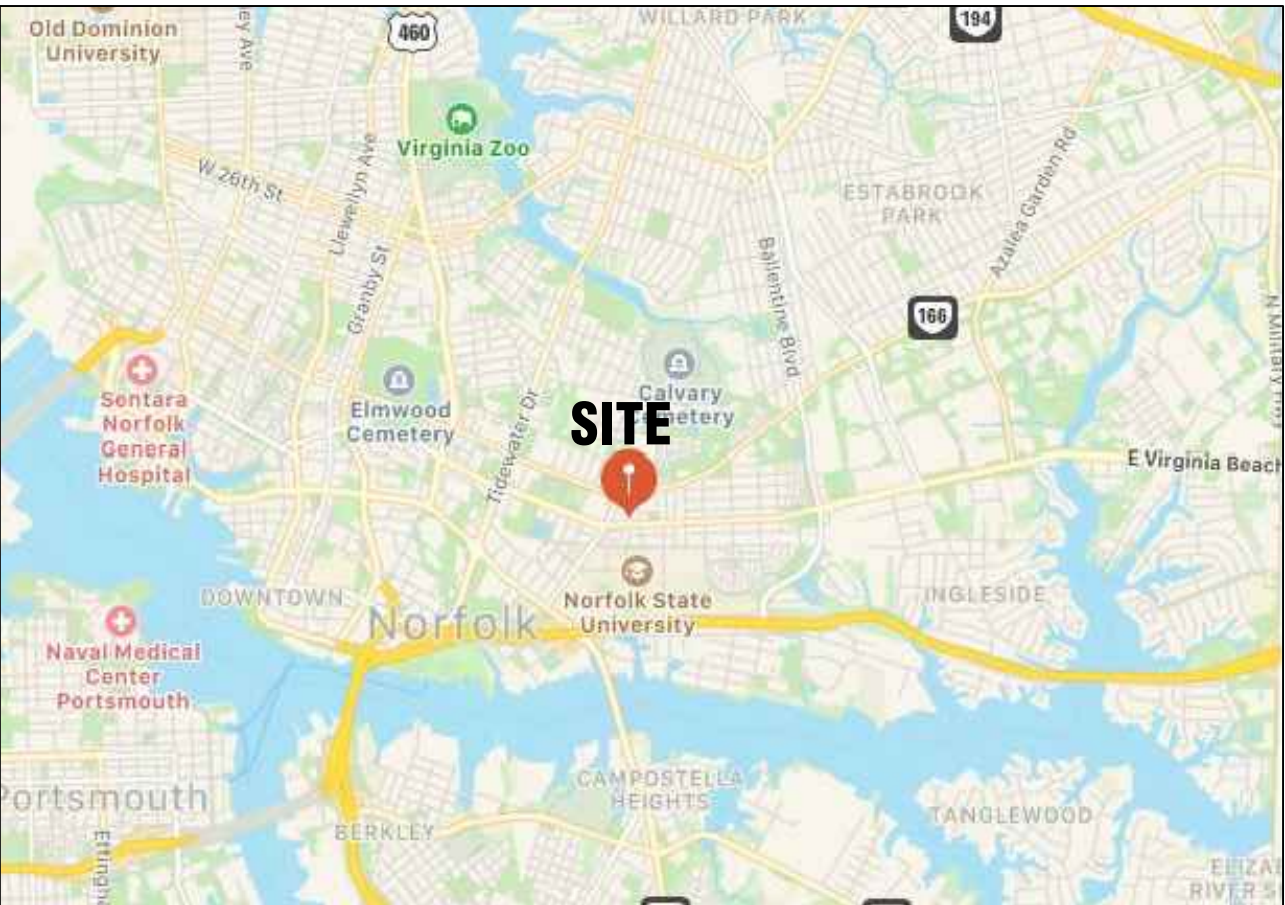

 VICINITY MAP
NTS

<u>GROSS AREA DATA</u>		
FLOOR 11	10,212	S.F.
FLOOR 10	10,200	S.F.
FLOOR 9	10,212	S.F.
FLOOR 8	10,200	S.F.
FLOOR 7	10,212	S.F.
FLOOR 6	10,200	S.F.
FLOOR 5	10,212	S.F.
FLOOR 4	10,200	S.F.
FLOOR 3	10,212	S.F.
FLOOR 2	10,200	S.F.
GRAND TOTAL	102,060	S.F.

[illegible]

ARCHITECTURAL AS BUILT
COGIC MEMORIAL HOME
NORFOLK, VA 23504

01	100% SUBMISSION	SEE COVER SHEET
NO.	ISSUES REVISIONS	DATE

SHEET TITLE

FLOOR 2
UNITS


HL	PROJECT MANAGER
HL	PROJECT DIRECTOR
	PROJECT NUMBER
1/4"=1'-0"	SCALE
MM	DRAWN BY
	SHEET NUMBER

AB-1




FLOOR 2

LINE LEGEND	
---	DROP SOFFIT
---	HOOD
---	TOP CABINET

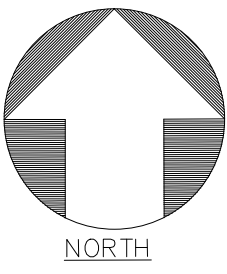



AB-2

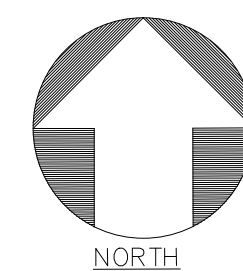




FLOOR 3

LINE LEGEND

- DROP SOFFIT
- HOOD
- TOP CABINET

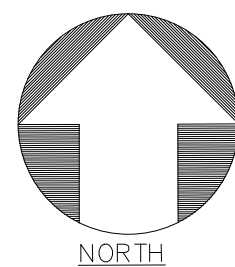

AS BUILT
PROFESSIONALS
www.asbuiltprofessionals.com
A DIVISION OF:
AEC
CONSULTANTS INC
844.272.8458
844 AS BUILT

© 2021 AEC CONSULTANTS INC

ARCHITECTURAL AS BUILT
COGIC MEMORIAL HOME
NORFOLK, VA 23504

01	100% SUBMISSION	SEE COVER SHEET
NO.	ISSUES REVISIONS	DATE

FLOOR 3
UNITS

HL	PROJECT MANAGER
HL	PROJECT DIRECTOR
	PROJECT NUMBER
1/4"=1'-0"	SCALE
MM	DRAWN BY
	SHEET NUMBER

AB-3


ARCHITECTURAL AS BUILT
COGIC MEMORIAL HOME
NORFOLK, VA 23504



FLOOR 3

LINE LEGEND

- DROP SOFFIT
- HOOD
- TOP CABINET

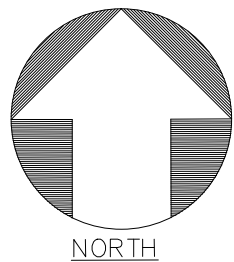

01	100% SUBMISSION	SEE COVER SHEET
NO.	ISSUES REVISIONS	DATE

FLOOR 3
UNITS

HL	PROJECT MANAGER
HL	PROJECT DIRECTOR
	PROJECT NUMBER
1/4"=1'-0"	SCALE
MM	DRAWN BY
	SHEET NUMBER



AB-4



ARCHITECTURAL AS BUILT

COGIC MEMORIAL HOME

NORFOLK, VA 23504

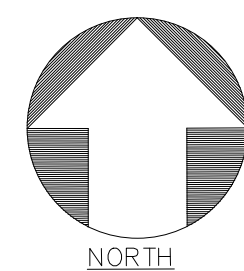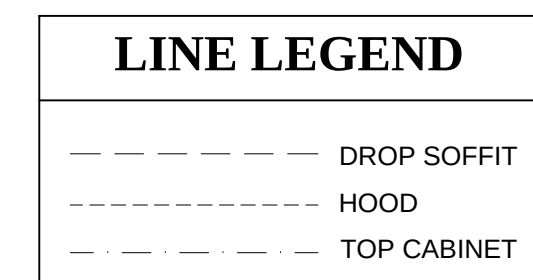

01	100% SUBMISSION	SEE COVER SHEET
NO.	ISSUES REVISIONS	DATE
		SHEET TITLE
FLOOR 4 UNITS		
HL	PROJECT MANAGER	
HL	PROJECT DIRECTOR	
	PROJECT NUMBER	
1/4"=1'-0"		SCALE
MM	DRAWN BY	
	SHEET NUMBER	

FLOOR 4

UNITS

AB-5


ARCHITECTURAL AS BUILT
COGIC MEMORIAL HOME
NORFOLK, VA 23504



FLOOR 4

LINE LEGEND

--- DROP SOFFIT
--- HOOD
--- TOP CABINET

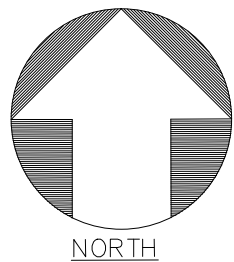



FLOOR 4
UNITS

HL	PROJECT MANAGER
HL	PROJECT DIRECTOR
	PROJECT NUMBER
1/4"=1'-0"	SCALE
MM	DRAWN BY
	SHEET NUMBER

AB-6



TECHNICAL AS BUILT
COGIC MEMORIAL HOME
NORFOLK, VA 23504

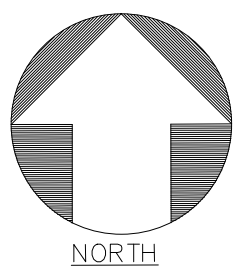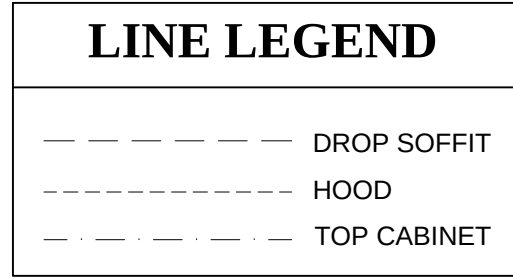

01	100% SUBMISSION	SEE COVER SHEET
NO.	ISSUES REVISIONS	DATE
		SHEET TITLE
FLOOR 5 UNITS		
HL		PROJECT MANAGER
HL		PROJECT DIRECTOR
		PROJECT NUMBER
1/4"=1'-0"		SCALE
MM		DRAWN BY
		SHEET NUMBER


AB-7

ARCHITECTURAL AS BUILT
COGIC MEMORIAL HOME
NORFOLK, VA 23504



FLOOR 5


LINE LEGEND	
---	DROP SOFFIT
---	HOOD
---	TOP CABINET

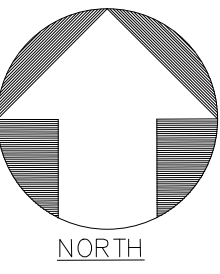

01	100% SUBMISSION	SEE COVER SHEET
NO.	ISSUES REVISIONS	DATE
		SHEET TITLE
FLOOR 5 UNITS		
HL	PROJECT MANAGER	
HL	PROJECT DIRECTOR	
	PROJECT NUMBER	
	SCALE	
1/4"=1'-0"		
MM	DRAWN BY	
	SHEET NUMBER	
AB-8		



TECHNICAL AS BUILT
COGIC MEMORIAL HOME
NORFOLK, VA 23504

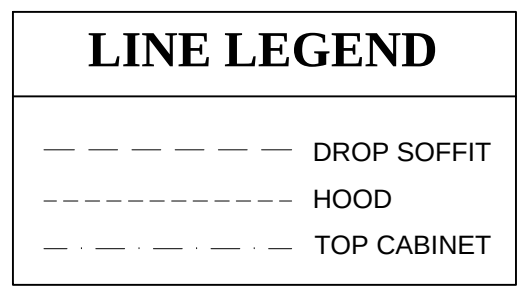

FLOOR 6 UNITS

01	100% SUBMISSION	SEE COVER SHEET
NO.	ISSUES REVISIONS	DATE
		SHEET TITLE
FLOOR 6 UNITS		
HL	PROJECT MANAGER	
HL	PROJECT DIRECTOR	
	PROJECT NUMBER	
1/4"=1'-0"		SCALE
MM	DRAWN BY	
	SHEET NUMBER	



AB-9



ARCHITECTURAL AS BUILT

COGIC MEMORIAL HOME

NORFOLK, VA 23504

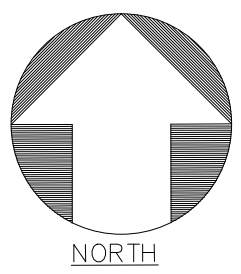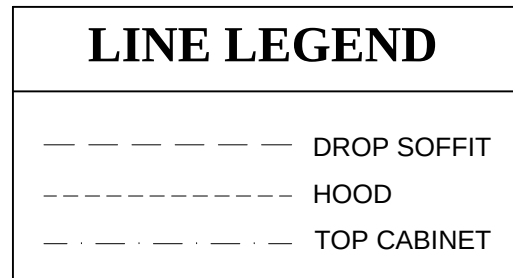

01	100% SUBMISSION	SEE COVER SHEET
NO.	ISSUES REVISIONS	DATE
		SHEET TITLE
FLOOR 6 UNITS		
HL		PROJECT MANAGER
HL		PROJECT DIRECTOR
		PROJECT NUMBER
1/4"=1'-0"		SCALE
MM		DRAWN BY
		SHEET NUMBER

FLOOR 6 UNITS


AB-10



FLOOR 7

LINE LEGEND

- DROP SOFFIT
- HOOD
- TOP CABINET

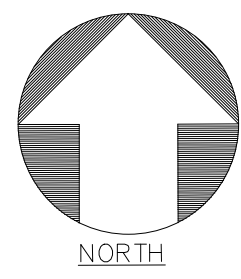

AS BUILT
PROFESSIONALS
www.asbuiltprofessionals.com
A DIVISION OF:
AEC
CONSULTANTS INC
844.272.8458
844 AS BUILT
© 2021 AEC CONSULTANTS INC

ARCHITECTURAL AS BUILT
COGIC MEMORIAL HOME
NORFOLK, VA 23504

01	100% SUBMISSION	SEE COVER SHEET
NO.	ISSUES REVISIONS	DATE
SHEET TITLE		
FLOOR 7 UNITS		
HL	PROJECT MANAGER	
HL	PROJECT DIRECTOR	
	PROJECT NUMBER	
	SCALE	
1/4"=1'-0"	DRAWN BY	
MM	SHEET NUMBER	
AB-11		


ARCHITECTURAL AS BUILT
COGIC MEMORIAL HOME
NORFOLK, VA 23504



FLOOR 7

LINE LEGEND

- DROP SOFFIT
- HOOD
- TOP CABINET

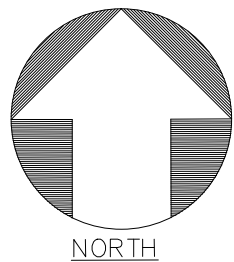

FLOOR 7
UNITS

HL	PROJECT MANAGER
HL	PROJECT DIRECTOR
	PROJECT NUMBER
1/4"=1'-0"	SCALE
MM	DRAWN BY
	SHEET NUMBER

AB-12


ARCHITECTURAL AS BUILT

COGIC MEMORIAL HOME

NORFOLK, VA 23504



LINE LEGEND	
---	DROP SOFFIT
---	HOOD
---	TOP CABINET

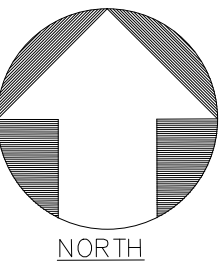

FLOOR 8
UNITS

HL	PROJECT MANAGER
HL	PROJECT DIRECTOR
	PROJECT NUMBER
1/4"=1'-0"	SCALE
MM	DRAWN BY
	SHEET NUMBER


AB-13

ARCHITECTURAL AS BUILT
COGIC MEMORIAL HOME
NORFOLK, VA 23504



FLOOR 8

LINE LEGEND	
---	DROP SOFFIT
---	HOOD
---	TOP CABINET

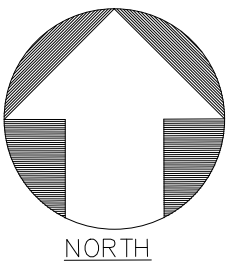



01	100% SUBMISSION	SEE COVER SHEET
NO.	ISSUES REVISIONS	DATE
SHEET TITLE		
FLOOR 8 UNITS		
HL	PROJECT MANAGER	
HL	PROJECT DIRECTOR	
	PROJECT NUMBER	
	SCALE	
1/4"=1'-0"		
MM	DRAWN BY	
	SHEET NUMBER	
AB-14		



STRUCTURAL AS BUILT

COGIC MEMORIAL HOME

NORFOLK, VA 23504

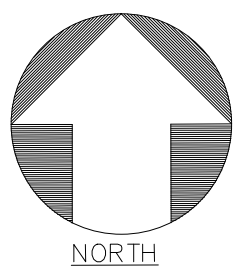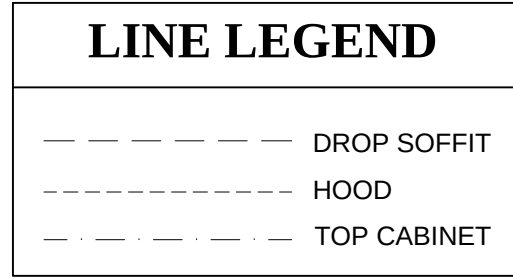

01	100% SUBMISSION	SEE COVER SHEET
NO.	ISSUES REVISIONS	DATE
		SHEET TITLE
FLOOR 9 UNITS		
HL	PROJECT MANAGER	
HL	PROJECT DIRECTOR	
	PROJECT NUMBER	
1/4"=1'-0"	SCALE	
MM	DRAWN BY	
	SHEET NUMBER	

AB-15



ARCHITECTURAL AS BUILT

COGIC MEMORIAL HOME

NORFOLK, VA 23504

01	100% SUBMISSION	SEE COVER SHEET
NO.	ISSUES REVISIONS	DATE
		SHEET TITLE

FLOOR 9 UNITS

HL	PROJECT MANAGER
HL	PROJECT DIRECTOR
	PROJECT NUMBER
1/4"=1'-0"	SCALE
MM	DRAWN BY
	SHEET NUMBER


AB-16




FLOOR 9

LINE LEGEND


— — — — —	DROP SOFFIT
- - - - -	HOOD
.	TOP CABINET

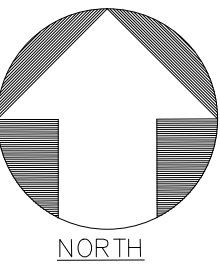

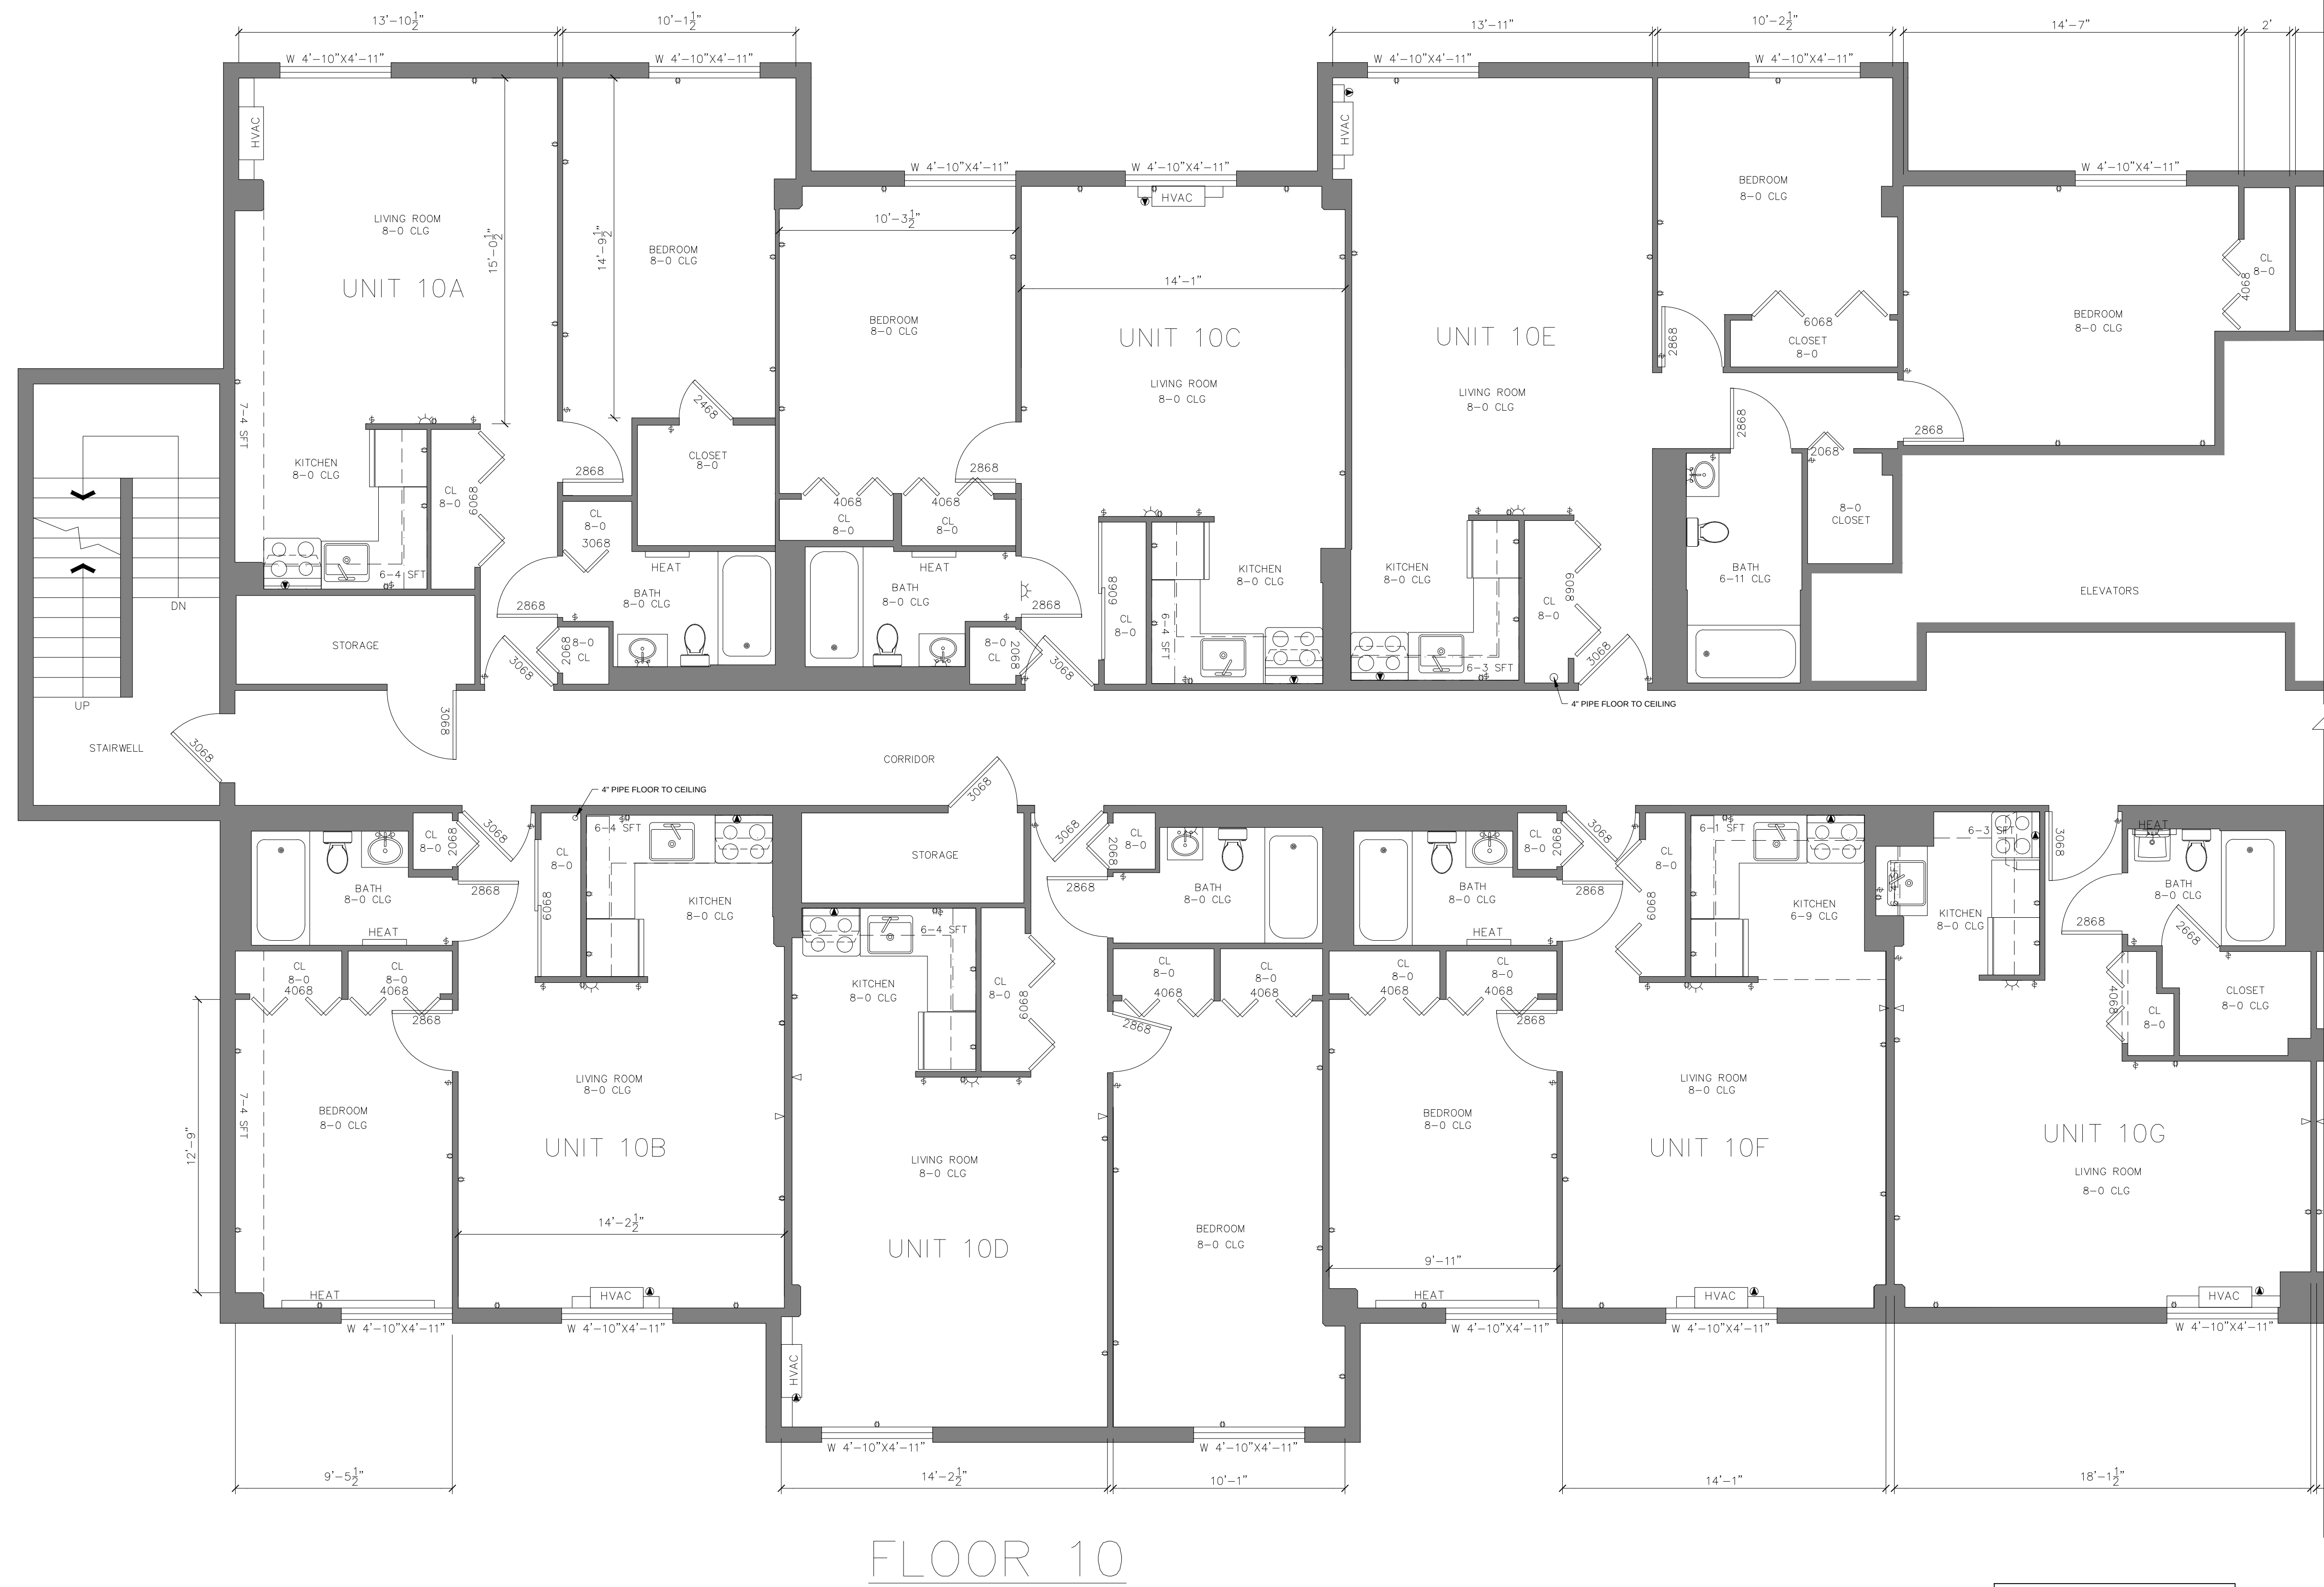

FLOOR 10

LINE LEGEND	
---	DROP SOFFIT
----	HOOD
- - - -	TOP CABINET

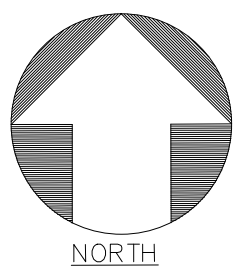


ARCHITECTURAL AS BUILT
COGIC MEMORIAL HOME
NORFOLK, VA 23504

01	100% SUBMISSION	SEE COVER SHEET
NO.	ISSUES REVISIONS	DATE

FLOOR 10
UNITS

HL	PROJECT MANAGER
HL	PROJECT DIRECTOR
	PROJECT NUMBER
	SCALE
MM	DRAWN BY
	SHEET NUMBER

 

NORFOLK, VA 23504



AB-18

ARCHITECTURAL AS BUILT


COGIC MEMORIAL HOME

NORFOLK, VA 23504



FLOOR 11

LINE LEGEND	
---	DROP SOFFIT
---	HOOD
---	TOP CABINET

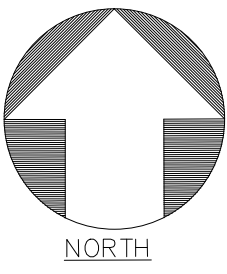

01	100% SUBMISSION	SEE COVER SHEET
NO.	ISSUES REVISIONS	DATE
		SHEET TITLE
FLOOR 11 UNITS		
HL	PROJECT MANAGER	
HL	PROJECT DIRECTOR	
	PROJECT NUMBER	
1/4"=1'-0"	SCALE	
MM	DRAWN BY	
	SHEET NUMBER	
AB-19		




STRUCTURAL AS BUILT
COGIC MEMORIAL HOME
NORFOLK, VA 23504



FLOOR 11

LINE LEGEND	
— — — — —	DROP SOFFIT
- - - - -	HOOD
.	TOP CABINET

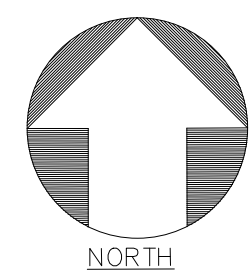

01	100% SUBMISSION	SEE COVER SHEET
NO.	ISSUES REVISIONS	DATE
		SHEET TITLE
FLOOR 11 UNITS		
HL		PROJECT MANAGER
HL		PROJECT DIRECTOR
		PROJECT NUMBER
1/4"=1'-0"		SCALE
MM		DRAWN BY
		SHEET NUMBER

AB-20