

AS-BUILT DOCUMENTATION

Franklin, NC 28734



100% SUBMITTAL

DRAWING INDEX

- 0C1 COVER
- 0SL SYMBOL LEGEND
- AB-0 SITE PLAN
- AB-1 FIRST FLOOR & RCP
- AB-2 SECOND FLOOR, RCP & ROOF PLAN
- AB-3 THIRD FLOOR & RCP
- AB-4 EXTERIOR ELEVATIONS
- AB-5 3D VIEWS

As BUILT

PROFESSIONALS

www.asbuiltprofessionals.com

A DIVISION OF:

AEC

CONSULTANTS INC


844.272.8458

844 A S B U I L T

© 2021 AEC CONSULTANTS INC

ARCHITECTURAL AS BUILT

Franklin, NC 28734

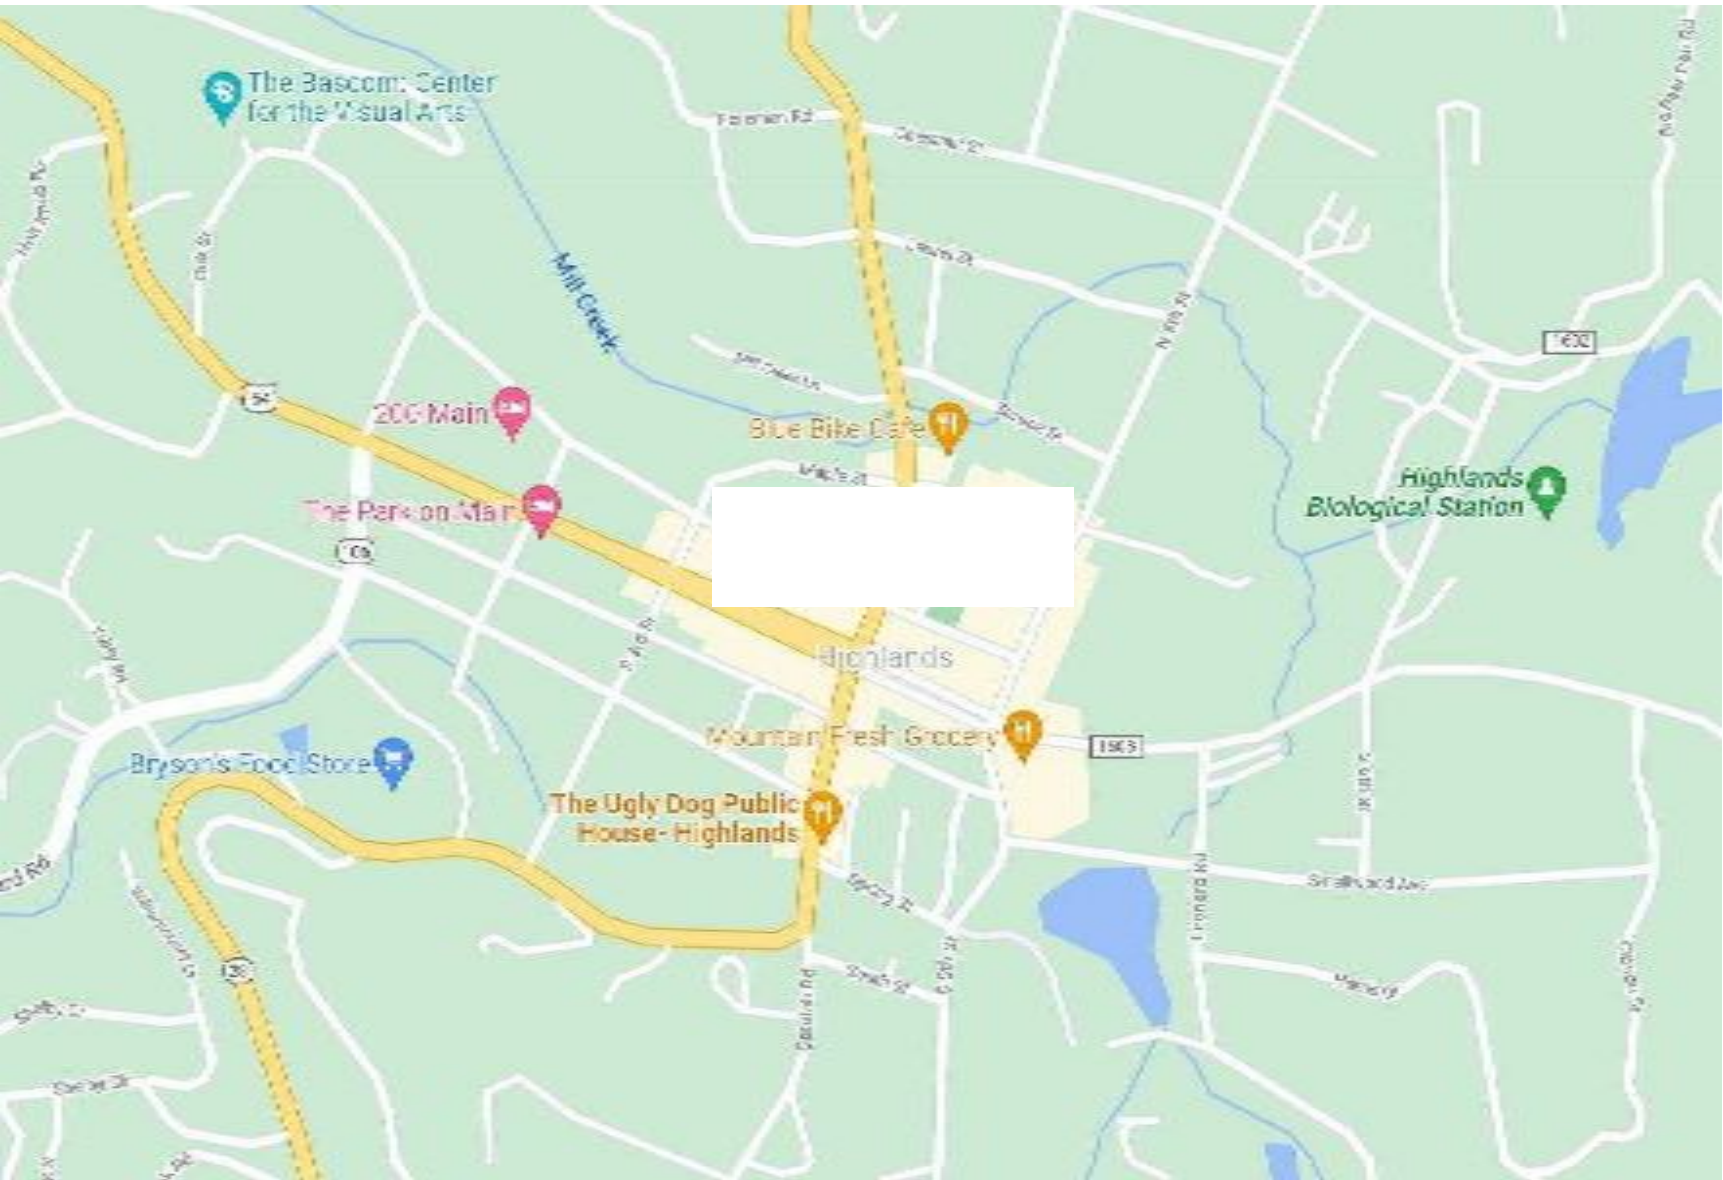

VICINITY MAP
N.T.S.

AREA DATA	
FIRST FLOOR	8871 SF
SECOND FLOOR	2878 SF
THIRD FLOOR	5494 SF
Grand total	17243 SF

01	100% SUBMISSION	SEE COVER SHEET
NO.	ISSUES / REVISIONS	DATE
SHEET TITLE		
COVER		
</		

SYMBOLS LEGEND			
RCP			
EXH		EXHAUST VENT	
L1		CEILING MOUNTED LIGHT FIXTURE	
L		CEILING MOUNTED DIRECTIONAL LIGHT	
RC		RECESSED CAN LIGHT	
EYE		EYEBALL OR SMALL CAN LIGHT	
HPL		PENDANT LIGHT	
FL		INDIVIDUAL FLUOR. LAY-IN FIXTURE 4 BULB	
FL2		INDIVIDUAL FLUOR. HANGING FIXTURE 2 BULB	
FL3		INDIVIDUAL FLUOR. FLUSH MOUNT FIXTURE 4 BULB	
C		CAMERA	
M		MOTION DET.	
SUP		SUPPLY VENT	
SUP2		SUPPLY VENT	
RET		RETURN VENT	
RET2		RETURN VENT	
spe		SPEAKER	
VL		TRACK LIGHT OR VANITY LIGHT	
NL		WALL-MOUNTED LIGHT FIXTURE	
ES		EMERGENCY EXIT SIGN	
EL		EMERGENCY EXIT LIGHT	
EEL		EMERGENCY EXIT LIGHT W/ SIGN	
STAIR		LIGHTED STAIR SIGN	
F		FLOOD LIGHT	
PC		PHOTO CELL	
F1		CEILING FAN	
F1LK		CEILING FAN W/ LIGHT KIT	
7-2-6		CEILING HEIGHT AND TRIM 7'-2" ABOVE FLOOR BELOW WITH 6" CROWN MOULDING. NOTE: ALL CEILINGS NOT LABELED ARE PLASTER. CEILINGS SHOWN WITH A GRID ARE LAY IN ACOUSTICAL TILE..	
J		JUNCTION BOX	
ELECTRIC			
DAT		DATA OUTLET	
TEL		TELEPHONE JACK	
S1		ELECTRIC SWITCH	
TV		CABLE TELEVISION OUTLET	
P1		DUPLEX RECEPTACLE OUTLET	
P3		SPECIAL PURPOSE CONNECTION OR OUTLET	
PQ		QUADRUPLX RECEPTACLE OUTLET	
PF		FLOOR DUPLEX RECEPTACLE OUTLET	
PNL		ELECTRIC PANEL	
MTR		ELECTRIC METER	
BUT		BUTTON SWITCH	
DISC		DISCONNECT SWITCH	
LG		GROUND/FLOOR LIGHT	
KP		KEY PAD	
FIRE PROTECTION			
FE		FIRE EXTINGUISHER	
FP		FIRE PULL	
AS		FIRE ALARM (HORN/SRTOBE)	
SD		SMOKE DETECTOR	
SS		SMOKE ALARM SPEAKER	
SP		SPRINKLER HEAD CEILING MOUNT	
SPW		SPRINKLER HEAD WALL MOUNT	
MEP			
TH		THERMOSTAT	
FD		FLOOR DRAIN	
V		VALVE	
HB		HOSE BIB	
WS		WATER SUPPLY	
HEAT		SUSPENDED GAS HEATER	
MISC			
BOLLARD		BOLLARD	
ELEVATION SYMBOL		11-4-11/16 SPOT ELEVATION	
INTERIOR ELEVATIONS			
BUILDING SECTION			
PHOTO DOCUMENTATION LEGEND			
INDICATES LOCATION OF CAMERA			
INDICATES DIRECTION OF CAMERA LENS AND CORRESPONDING PHOTO / VIDEO NUMBER			
TYPES OF DOCUMENTATION			
PS (SMALL) PL (LARGE)	GROUND BASED PHOTO	GROUND BASED VIDEO	360° SPHERICAL PHOTO
V-001	GROUND BASED VIDEO	360° SPHERICAL PHOTO	AERIAL BASED PHOTO
000	GROUND BASED PHOTO	360° SPHERICAL PHOTO	AERIAL BASED VIDEO
V-000	GROUND BASED VIDEO	360° SPHERICAL PHOTO	AERIAL BASED VIDEO

ARCHITECTURAL AS BUILT

Franklin, NC 28734

SYMBOL LEGEND

Designer	PROJECT MANAGER
Designer	PROJECT DIRECTOR
Project Number	PROJECT NUMBER
	SCALE
Author	DRAWN BY
	SHEET NUMBER

OSL

[illegible]

ARCHITECTURAL AS BUILT


Franklin, NC 28734

[illegible]

SITE PLAN

Designer	PROJECT MANAGER
Designer	PROJECT DIRECTOR
Project Number	PROJECT NUMBER
	SCALE
Author	DRAWN BY
	CHECK NUMBER


AB-0

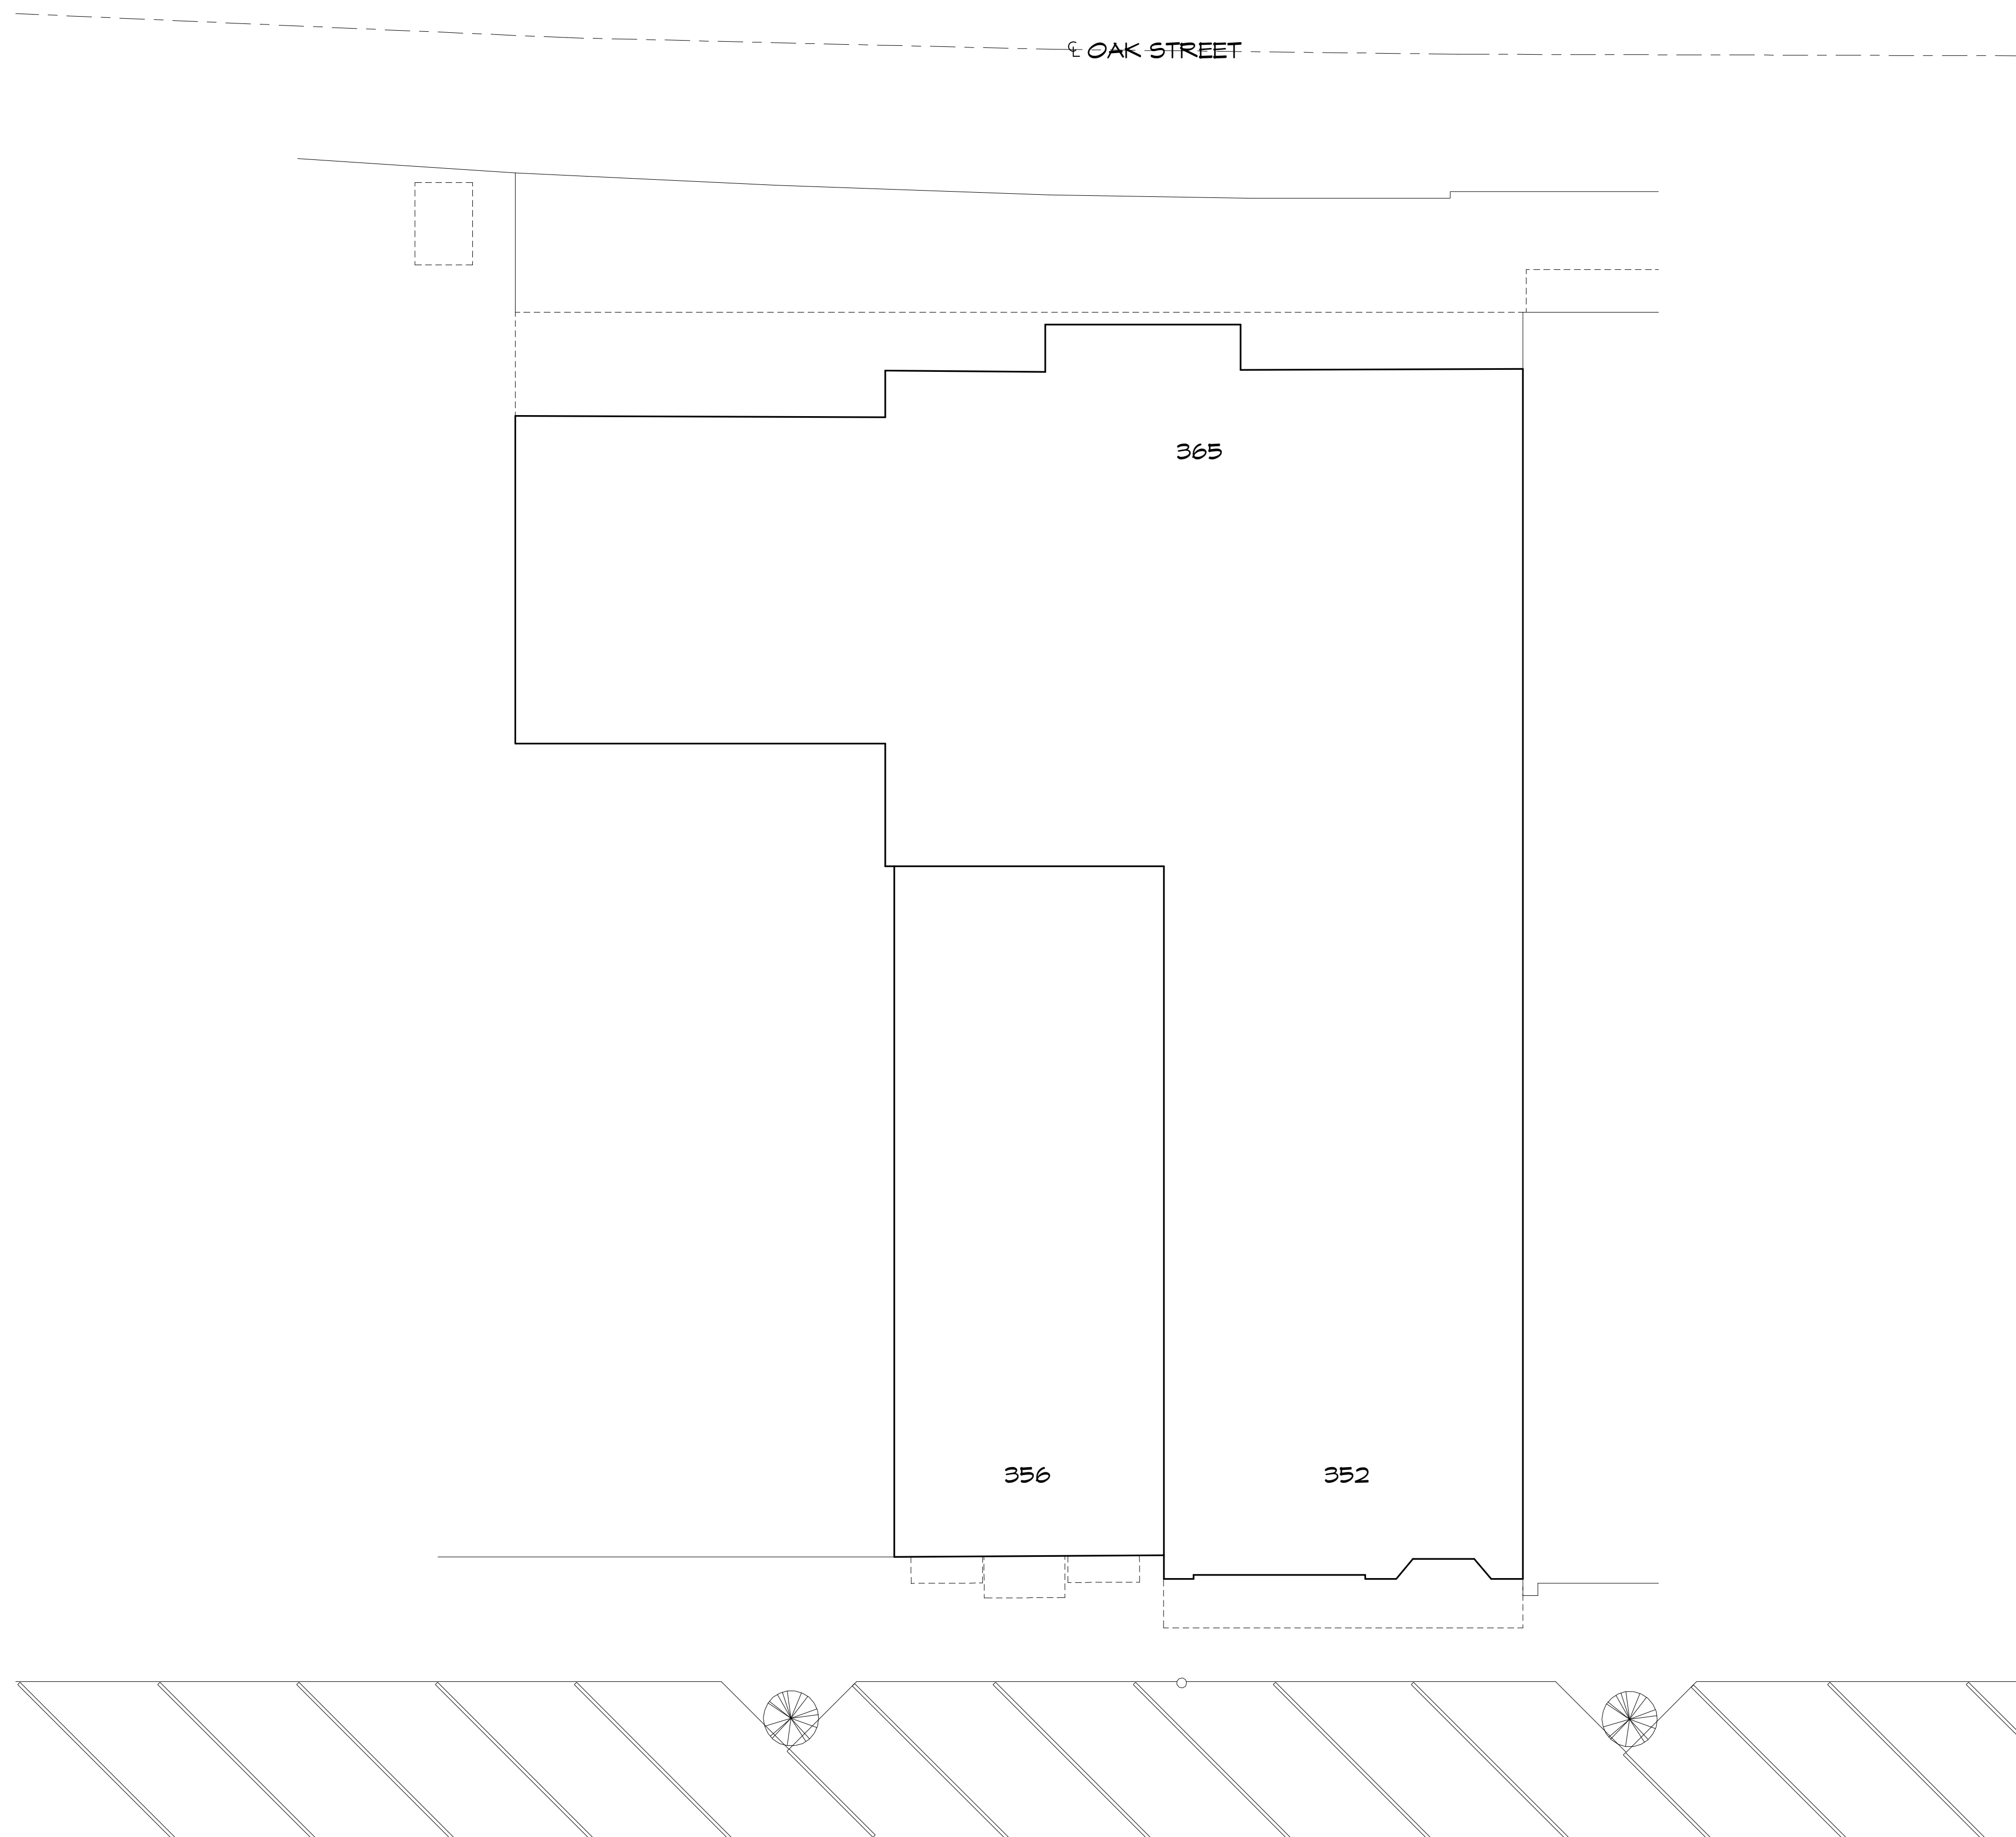


MAIN STREET

1 SITE PLAN
1" = 10'-0"

1

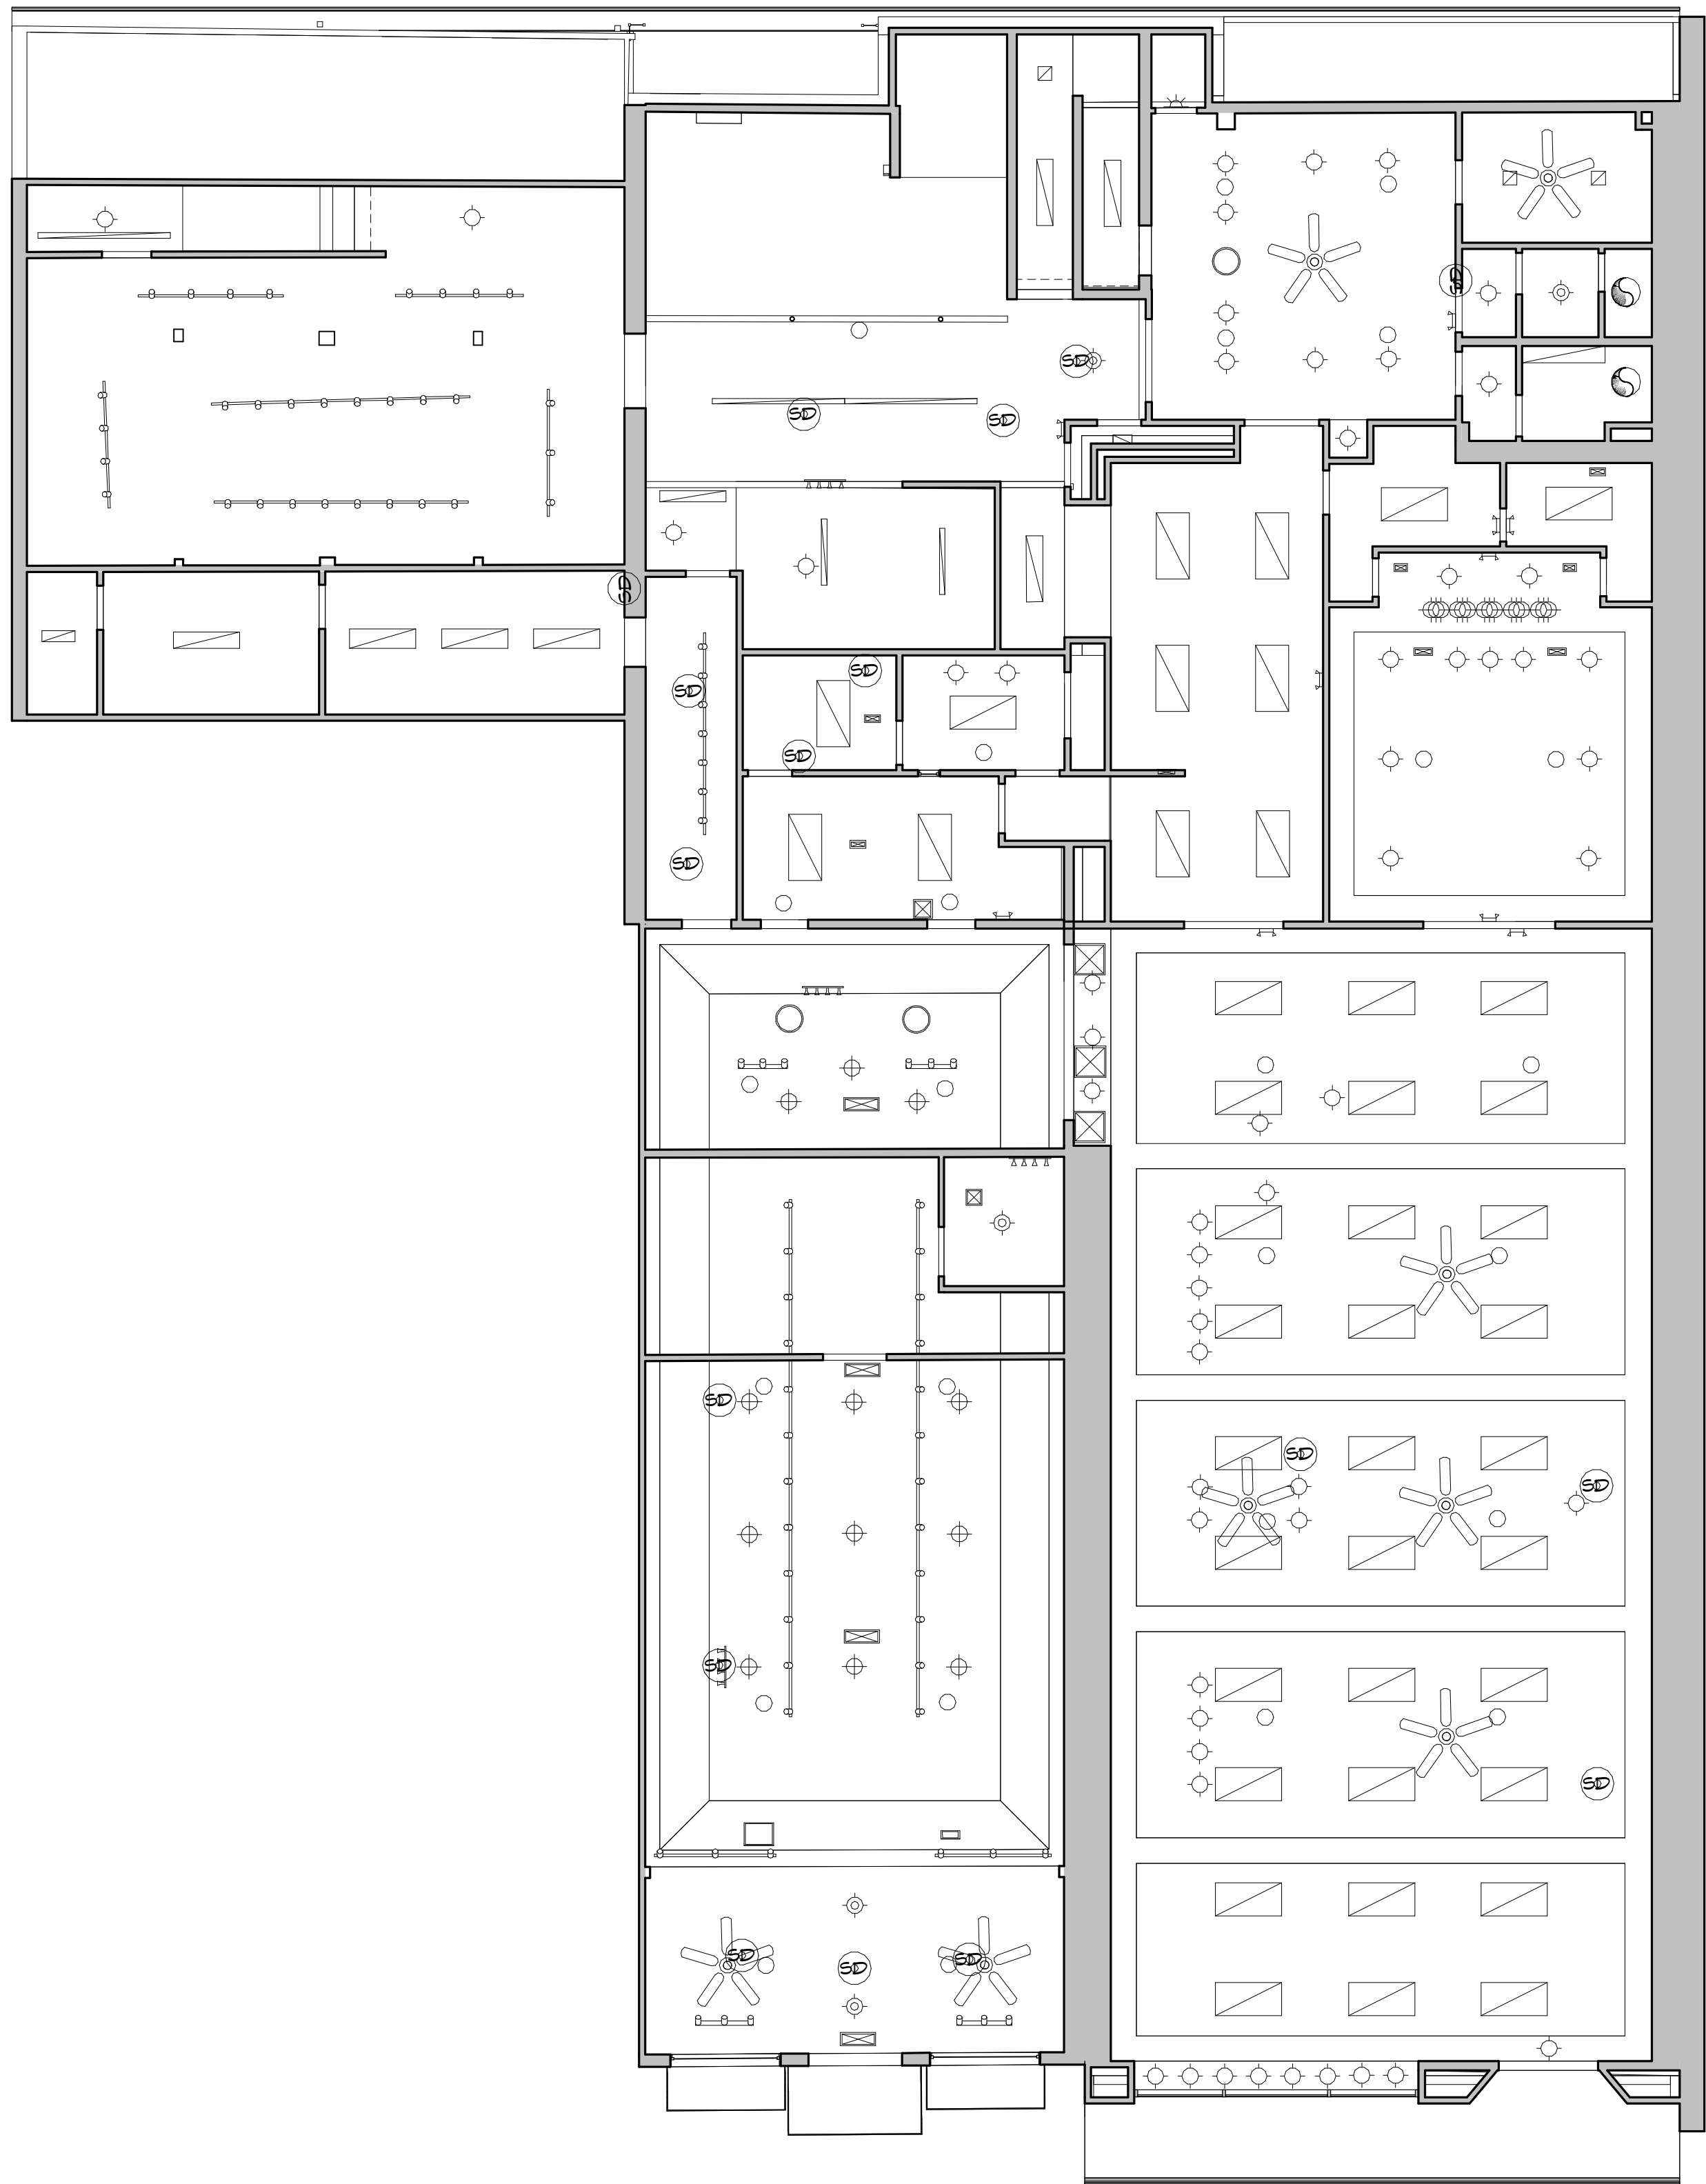

2 FIRST FLOOR REFLECTED CEILING PLAN
1/8" = 1'-0"

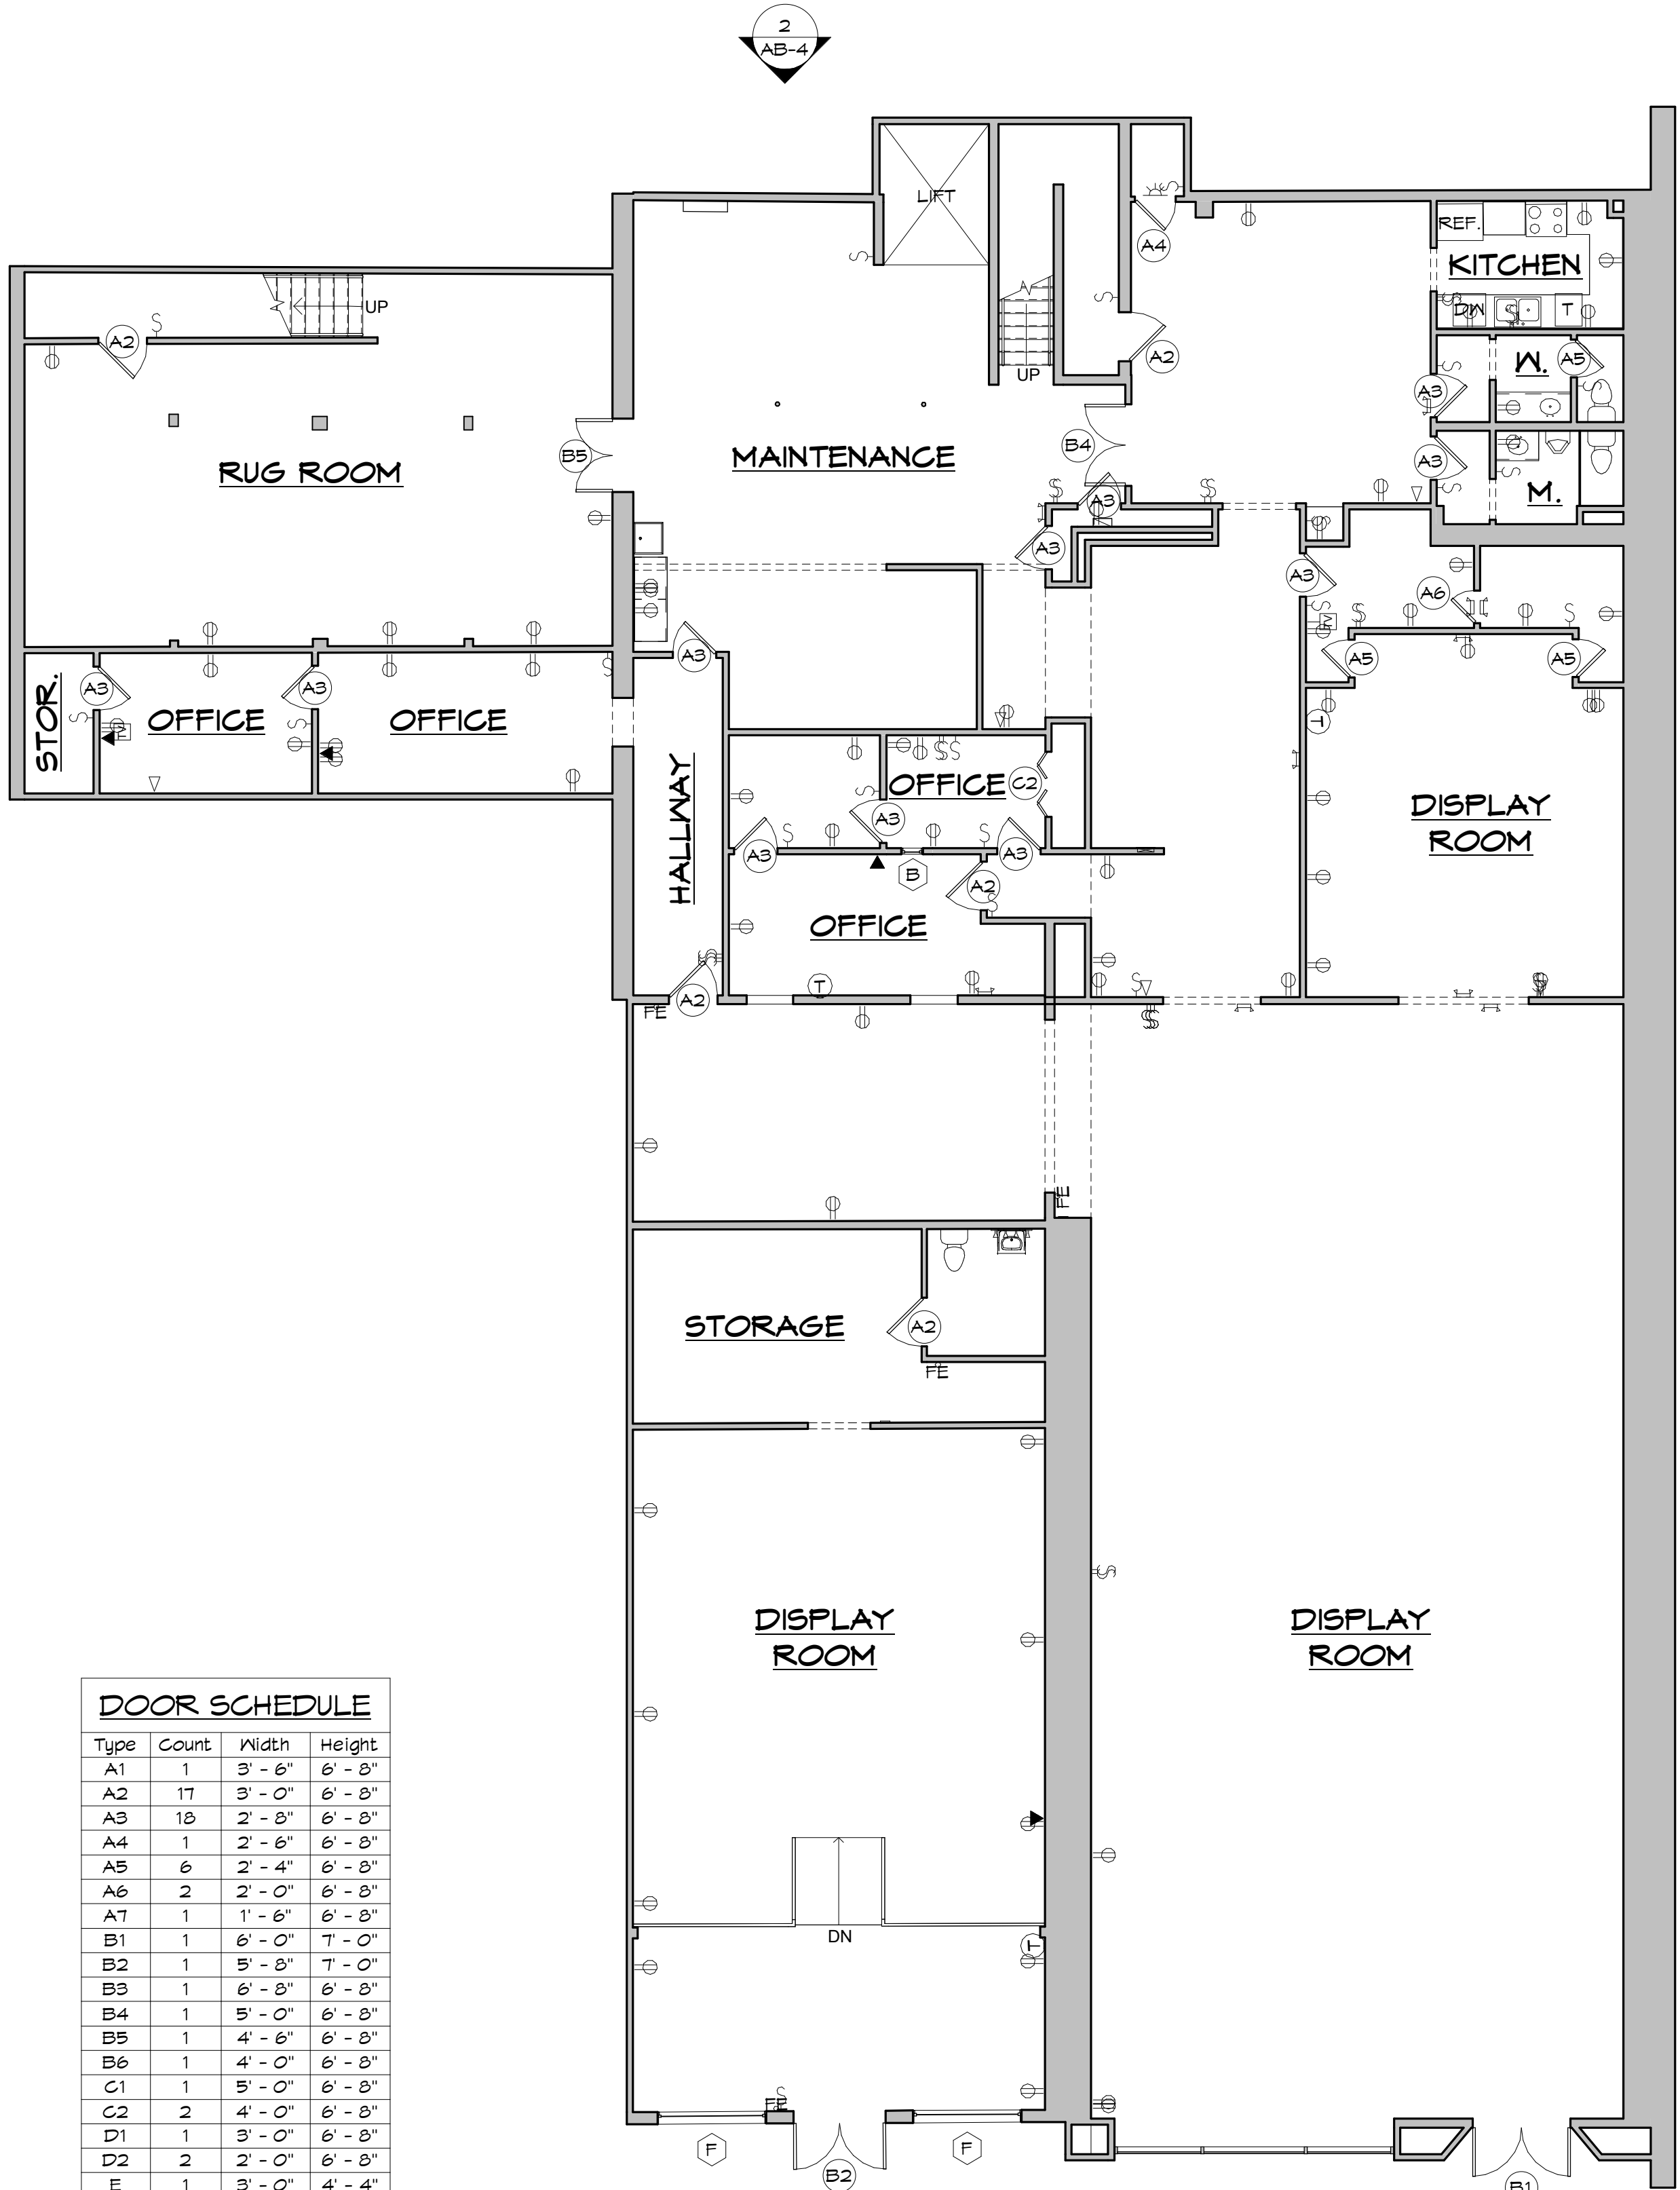

DOOR SCHEDULE			
Type	Count	Width	Height
A1	1	3' - 6"	6' - 8"
A2	17	3' - 0"	6' - 8"
A3	18	2' - 8"	6' - 8"
A4	1	2' - 6"	6' - 8"
A5	6	2' - 4"	6' - 8"
A6	2	2' - 0"	6' - 8"
A7	1	1' - 6"	6' - 8"
B1	1	6' - 0"	7' - 0"
B2	1	5' - 8"	7' - 0"
B3	1	6' - 8"	6' - 8"
B4	1	5' - 0"	6' - 8"
B5	1	4' - 6"	6' - 8"
B6	1	4' - 0"	6' - 8"
C1	1	5' - 0"	6' - 8"
C2	2	4' - 0"	6' - 8"
D1	1	3' - 0"	6' - 8"
D2	2	2' - 0"	6' - 8"
E	1	3' - 0"	4' - 4"
F	1	6' - 0"	8' - 0"

WINDOW SCHEDULE			
Type	Count	Width	Height
A	3	3' - 0"	6' - 6"
B	1	1' - 4"	2' - 0"
C	4	6' - 0"	2' - 0"
D	2	6' - 8"	1' - 8"
E	2	4' - 11"	5' - 4"
F	2	6' - 8"	5' - 6"


1 FIRST FLOOR
1/8" = 1'-0"

ARCHITECTURAL AS BUILT
Franklin, NC 28734


NO.	01	100% SUBMISSION	SEE COVER SHEET
ISSUES / REVISIONS			DATE
SHEET TITLE			

FIRST FLOOR & RCP


Designer	PROJECT MANAGER
Designer	PROJECT DIRECTOR
Project Number	PROJECT NUMBER
Author	DRAWN BY
	SHEET NUMBER

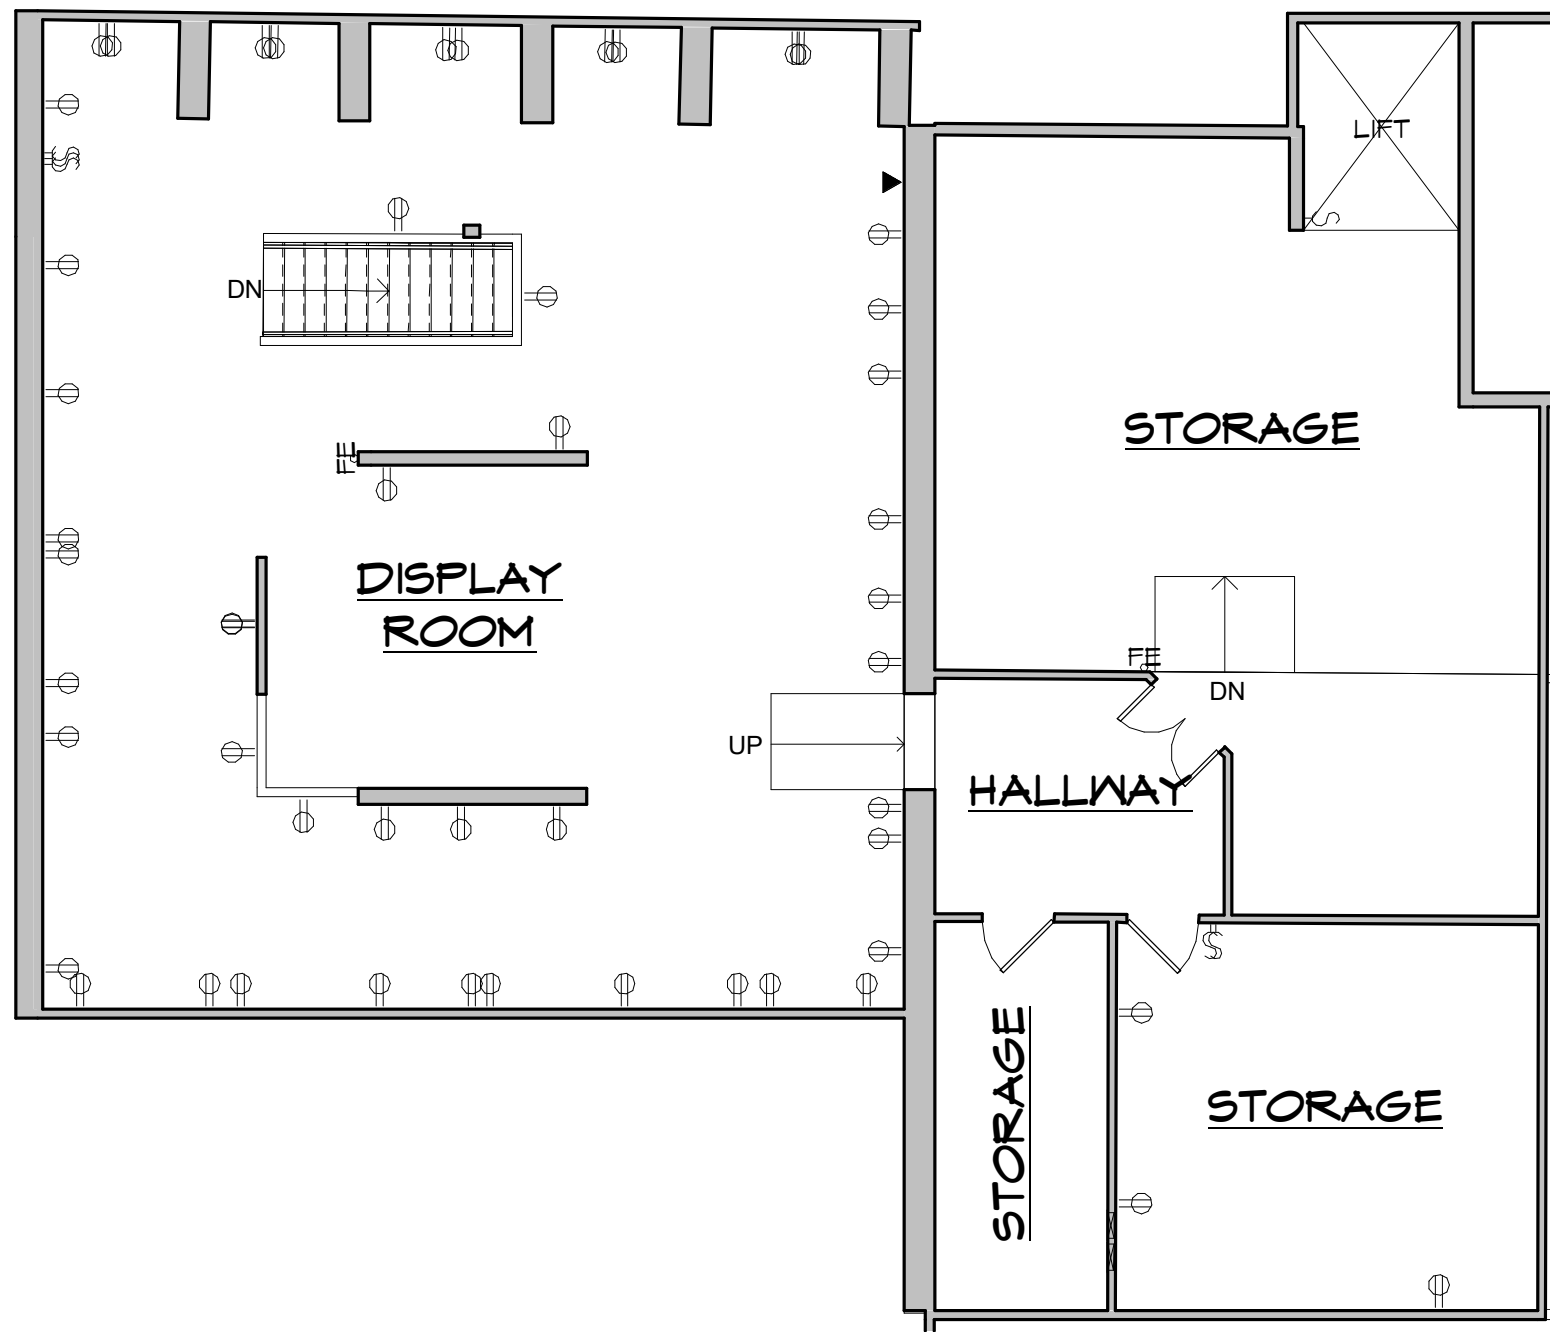

2 SECOND FLOOR
1/8" = 1'-0"

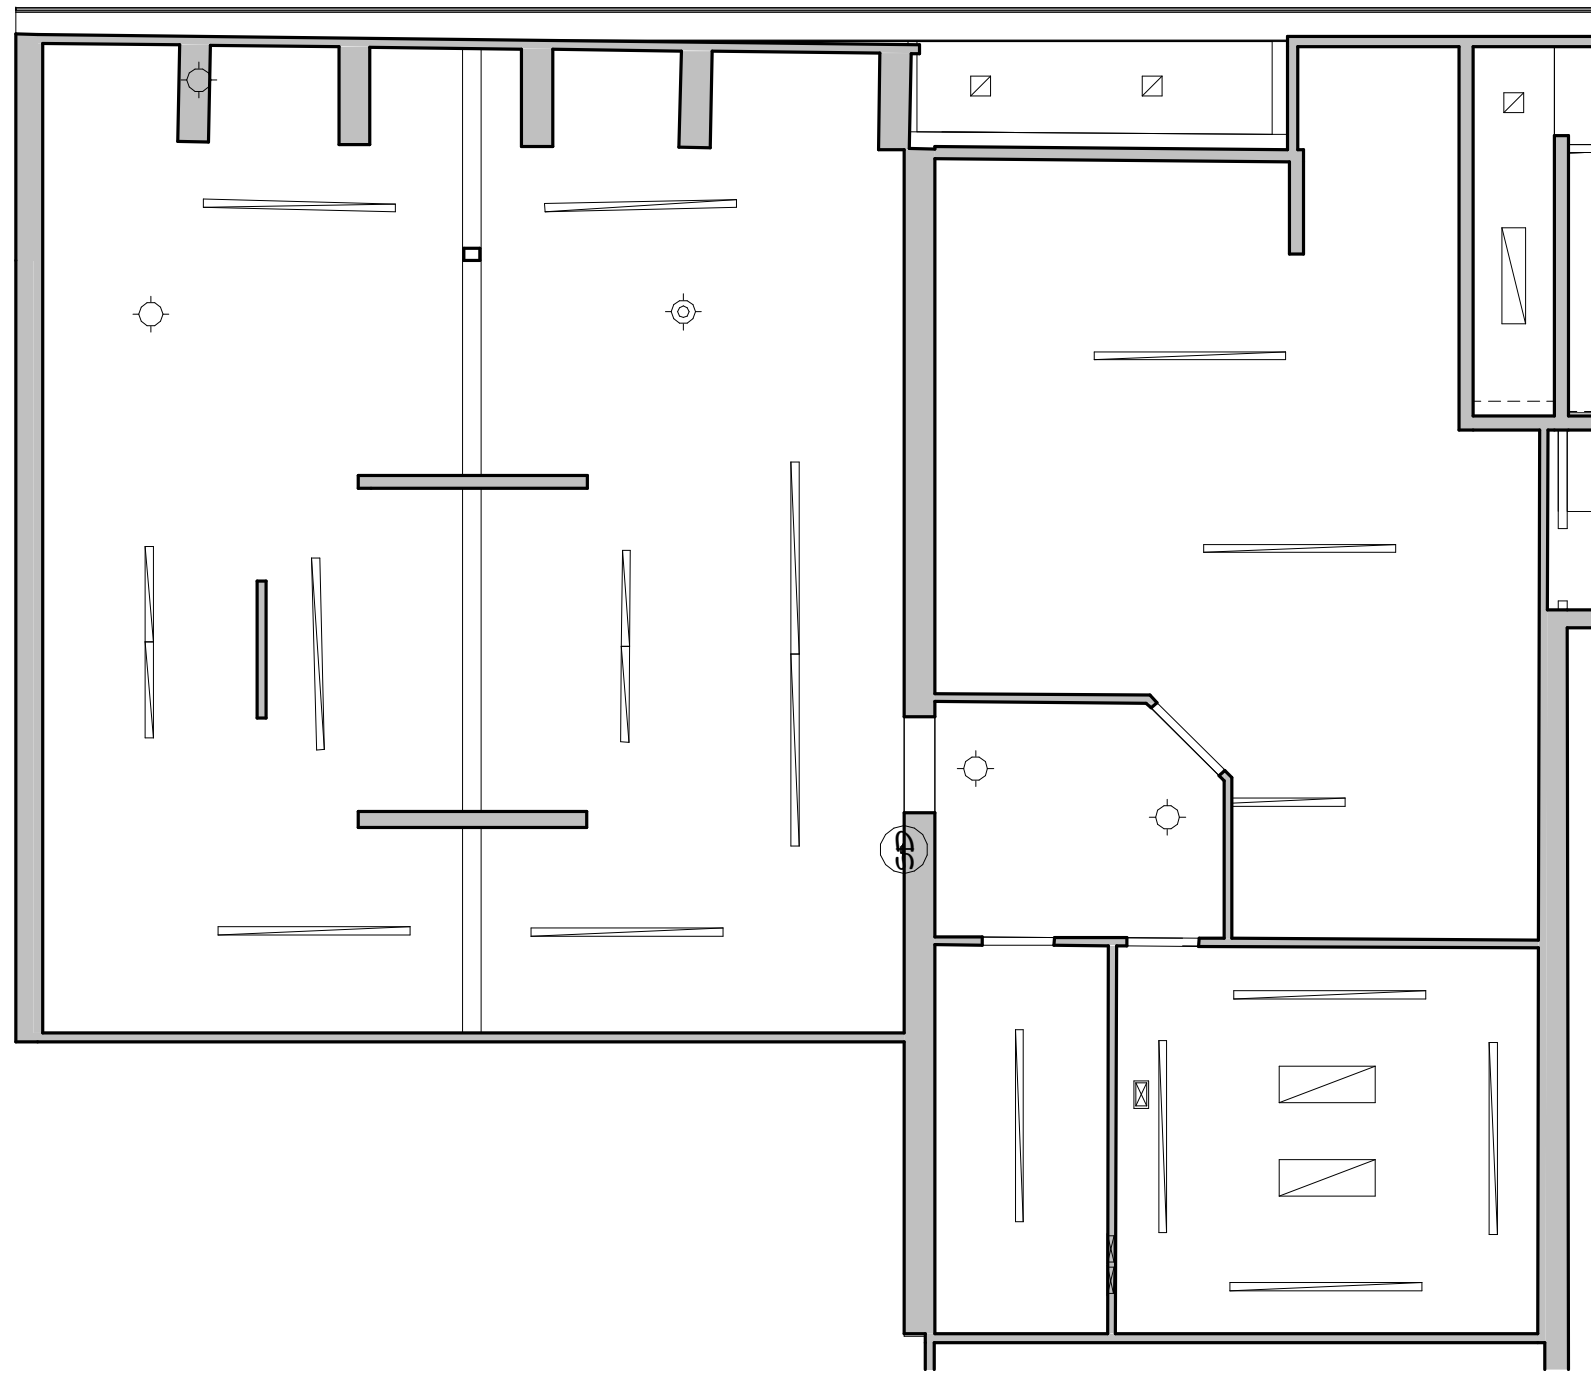

3 SECOND FLOOR REFLECTED CEILING PLAN
1/8" = 1'-0"

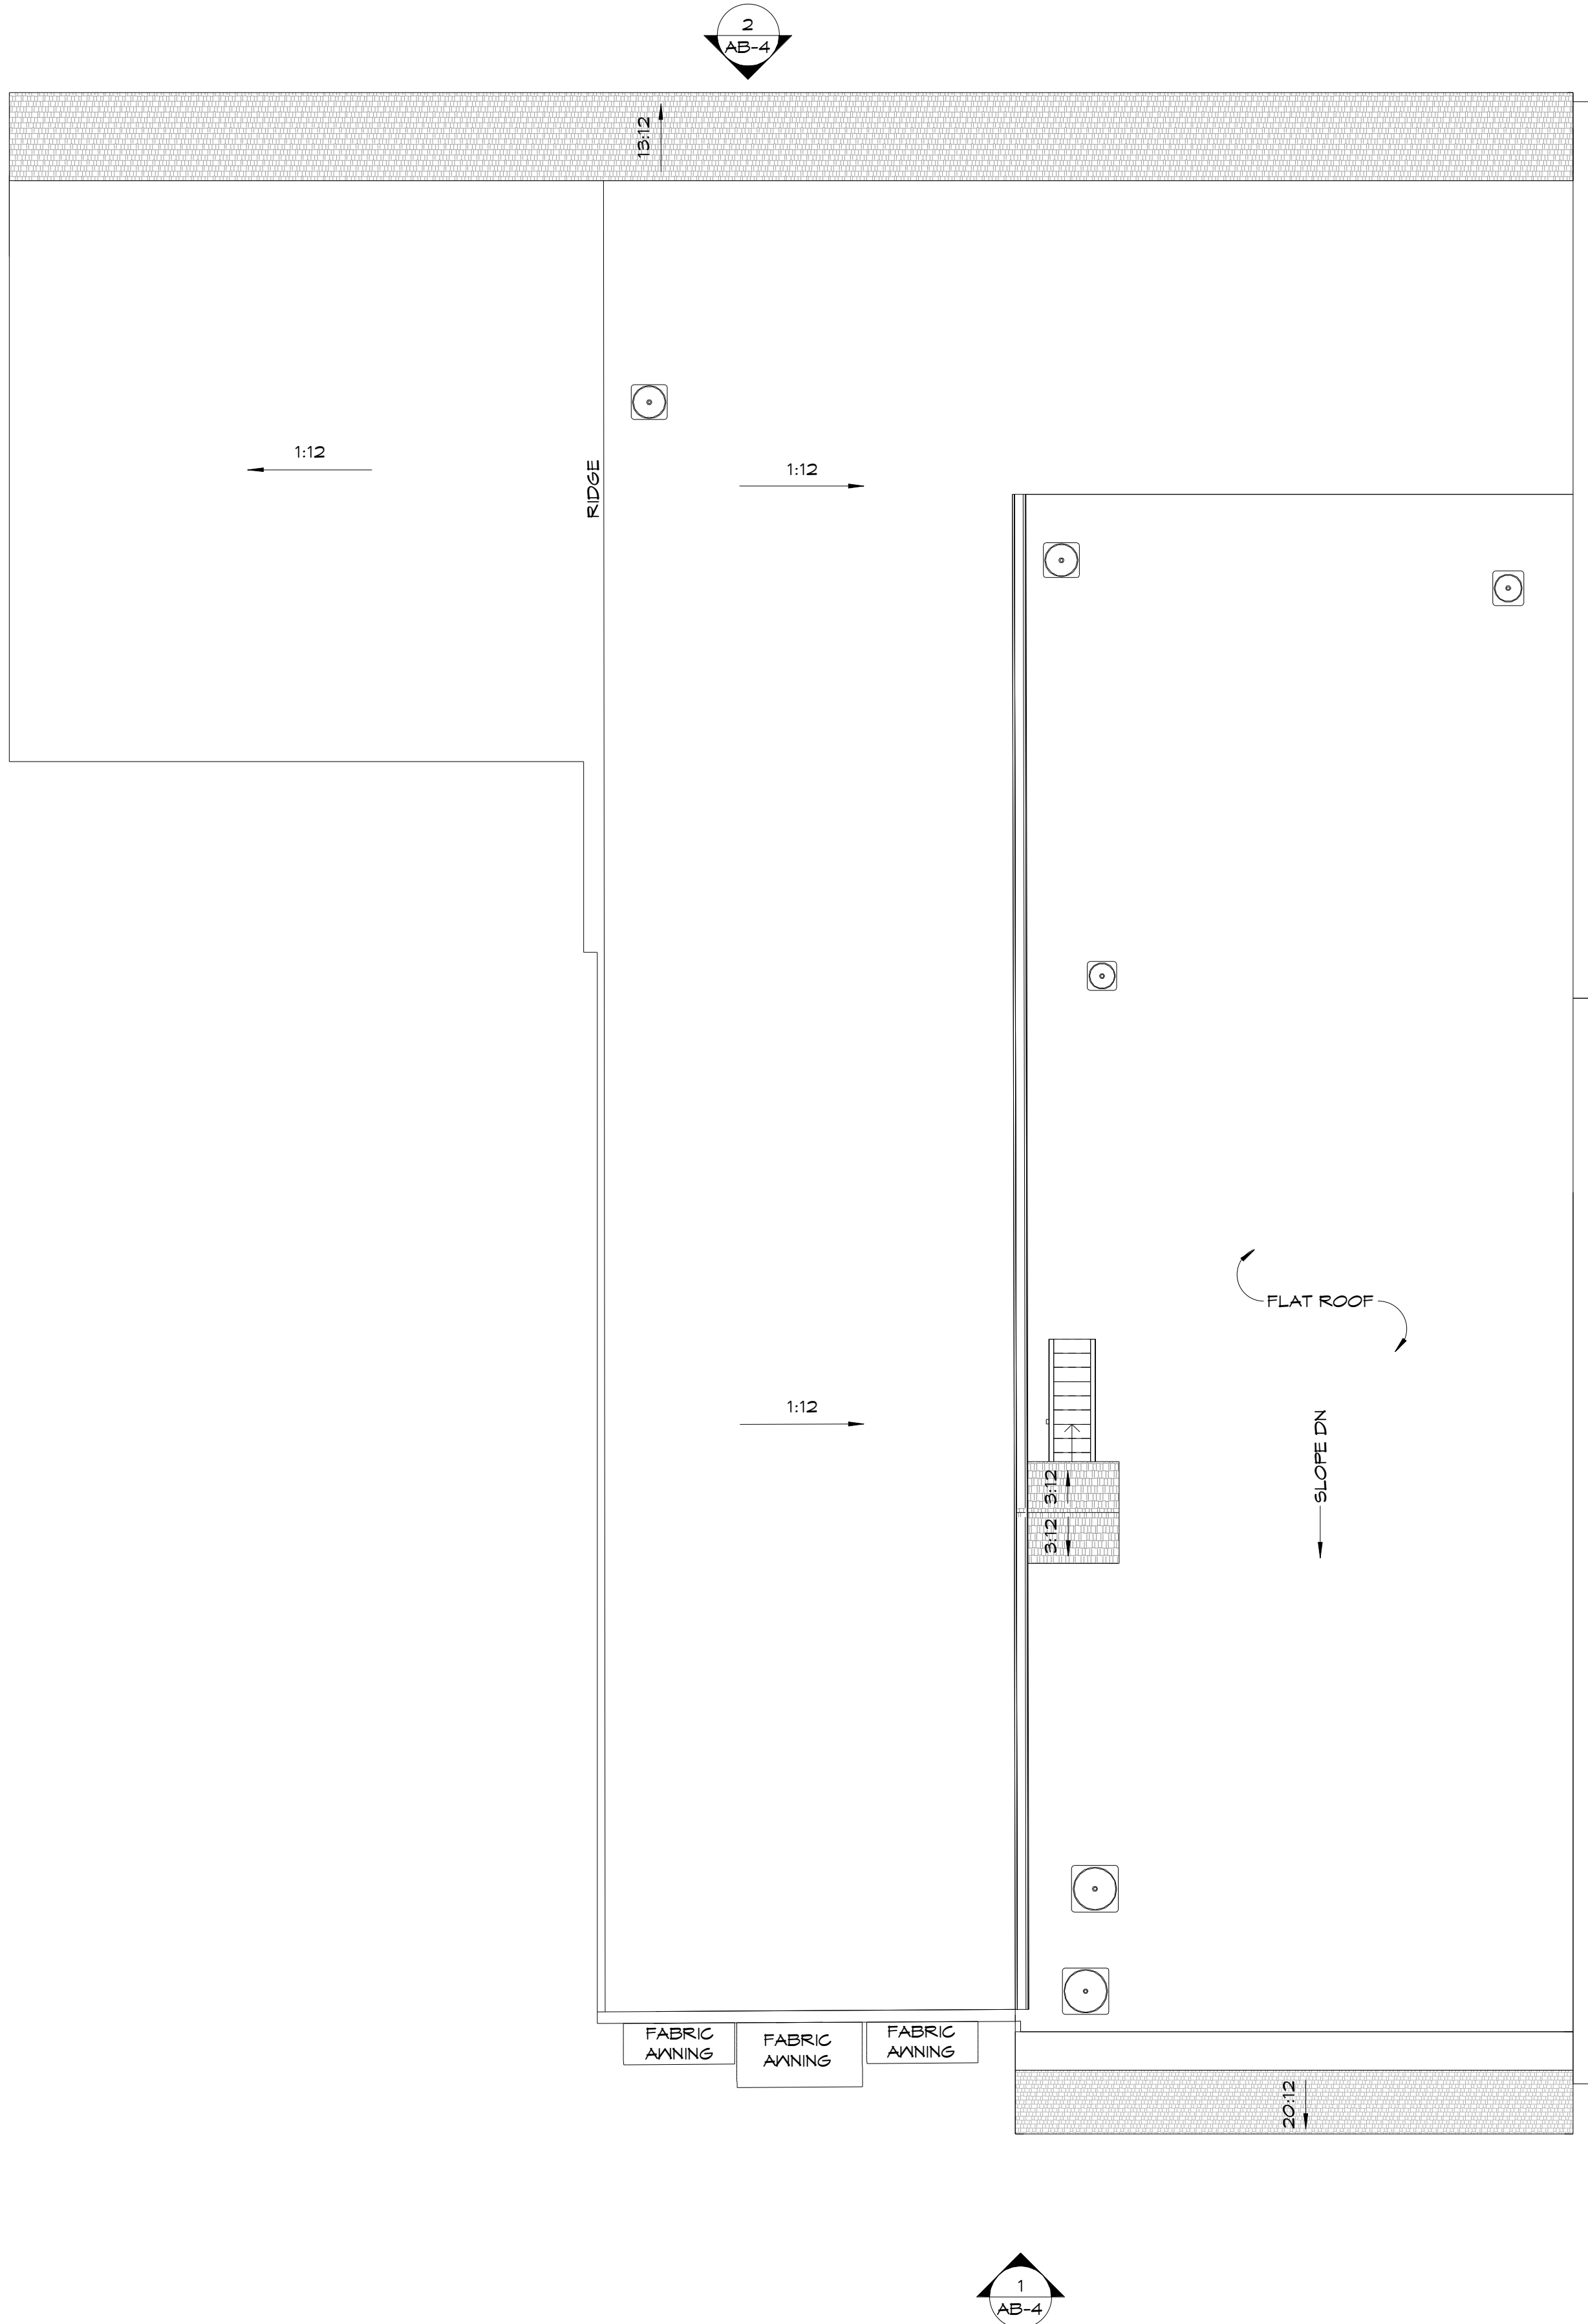

1 ROOF PLAN
1/8" = 1'-0"

As BUILT

PROFESSIONALS

www.asbuiltprofessionals.com

A DIVISION OF:

AEC

CONSULTANTS INC

844.272.8458

844 A S B U I L T

© 2021 AEC CONSULTANTS INC

ARCHITECTURAL AS BUILT


Franklin, NC 28734

01	100% SUBMISSION	SEE COVER SHEET
NO.	ISSUES / REVISIONS	DATE


SECOND FLOOR, RCP & ROOF PLAN

Designer	PROJECT MANAGER
Designer	PROJECT DIRECTOR
Project Number	PROJECT NUMBER
Author	DRAWN BY

AB-2

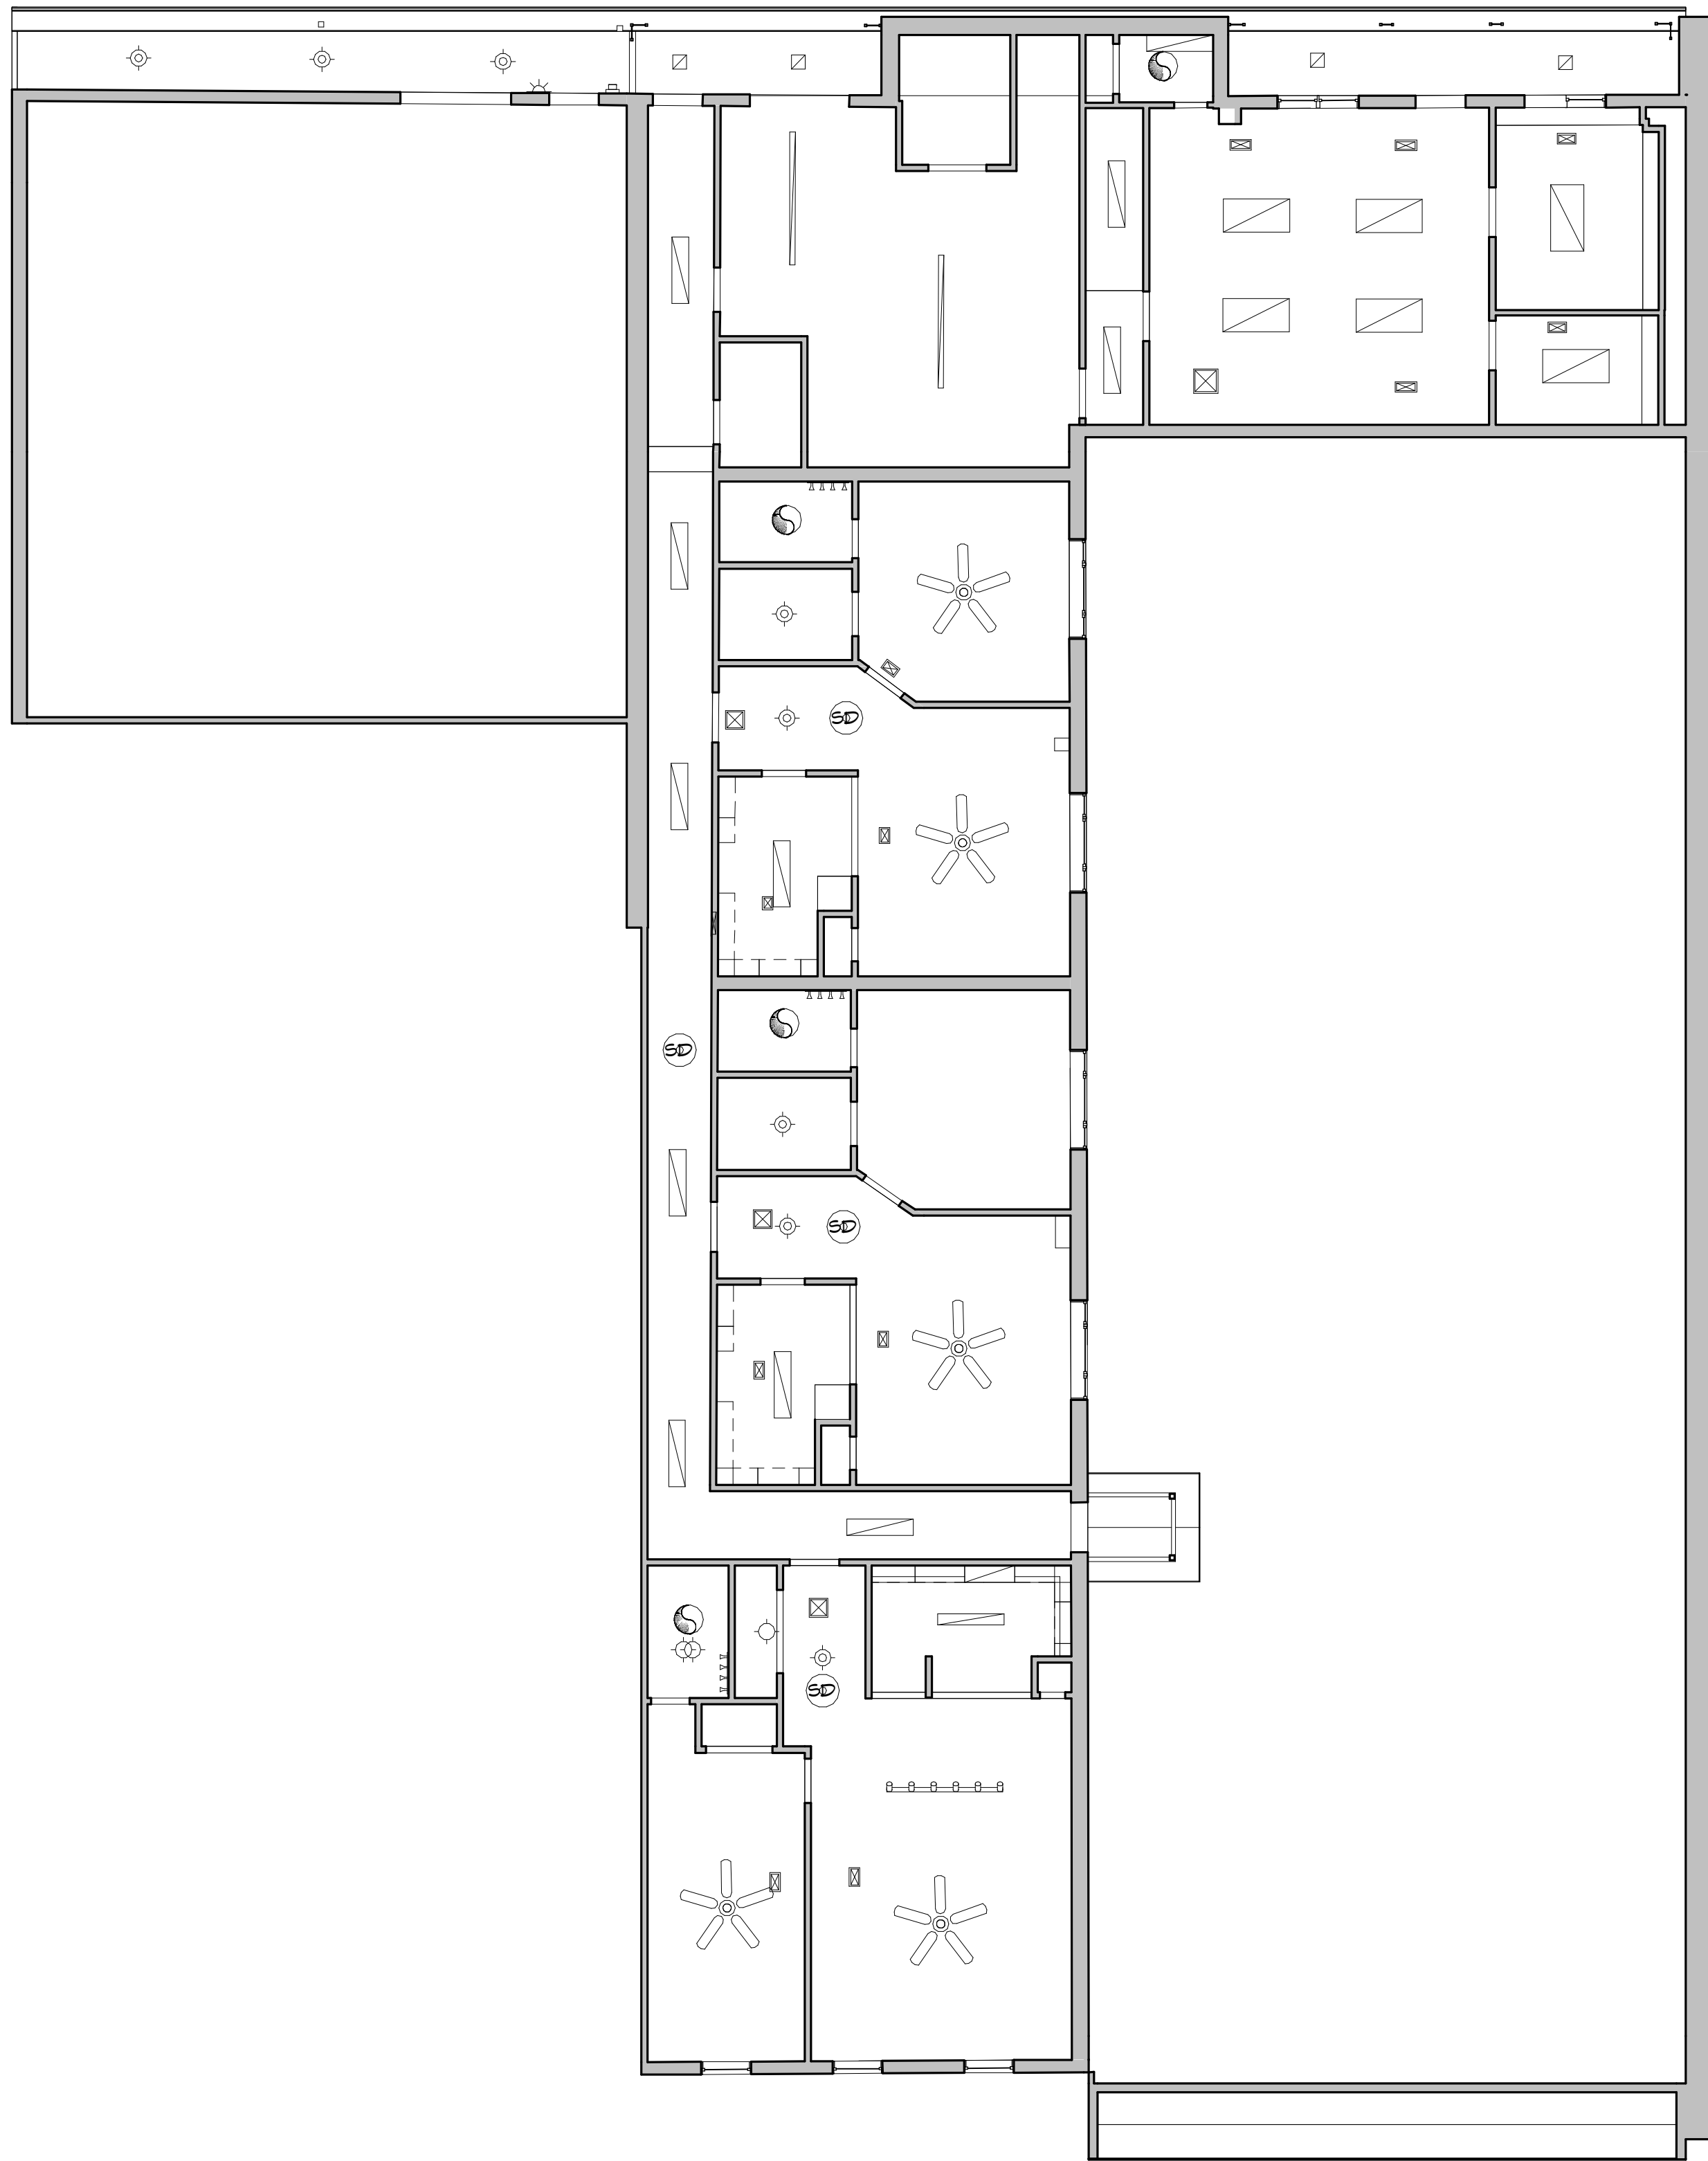

2 THIRD FLOOR REFLECTED CEILING PLAN
1/8" = 1'-0"

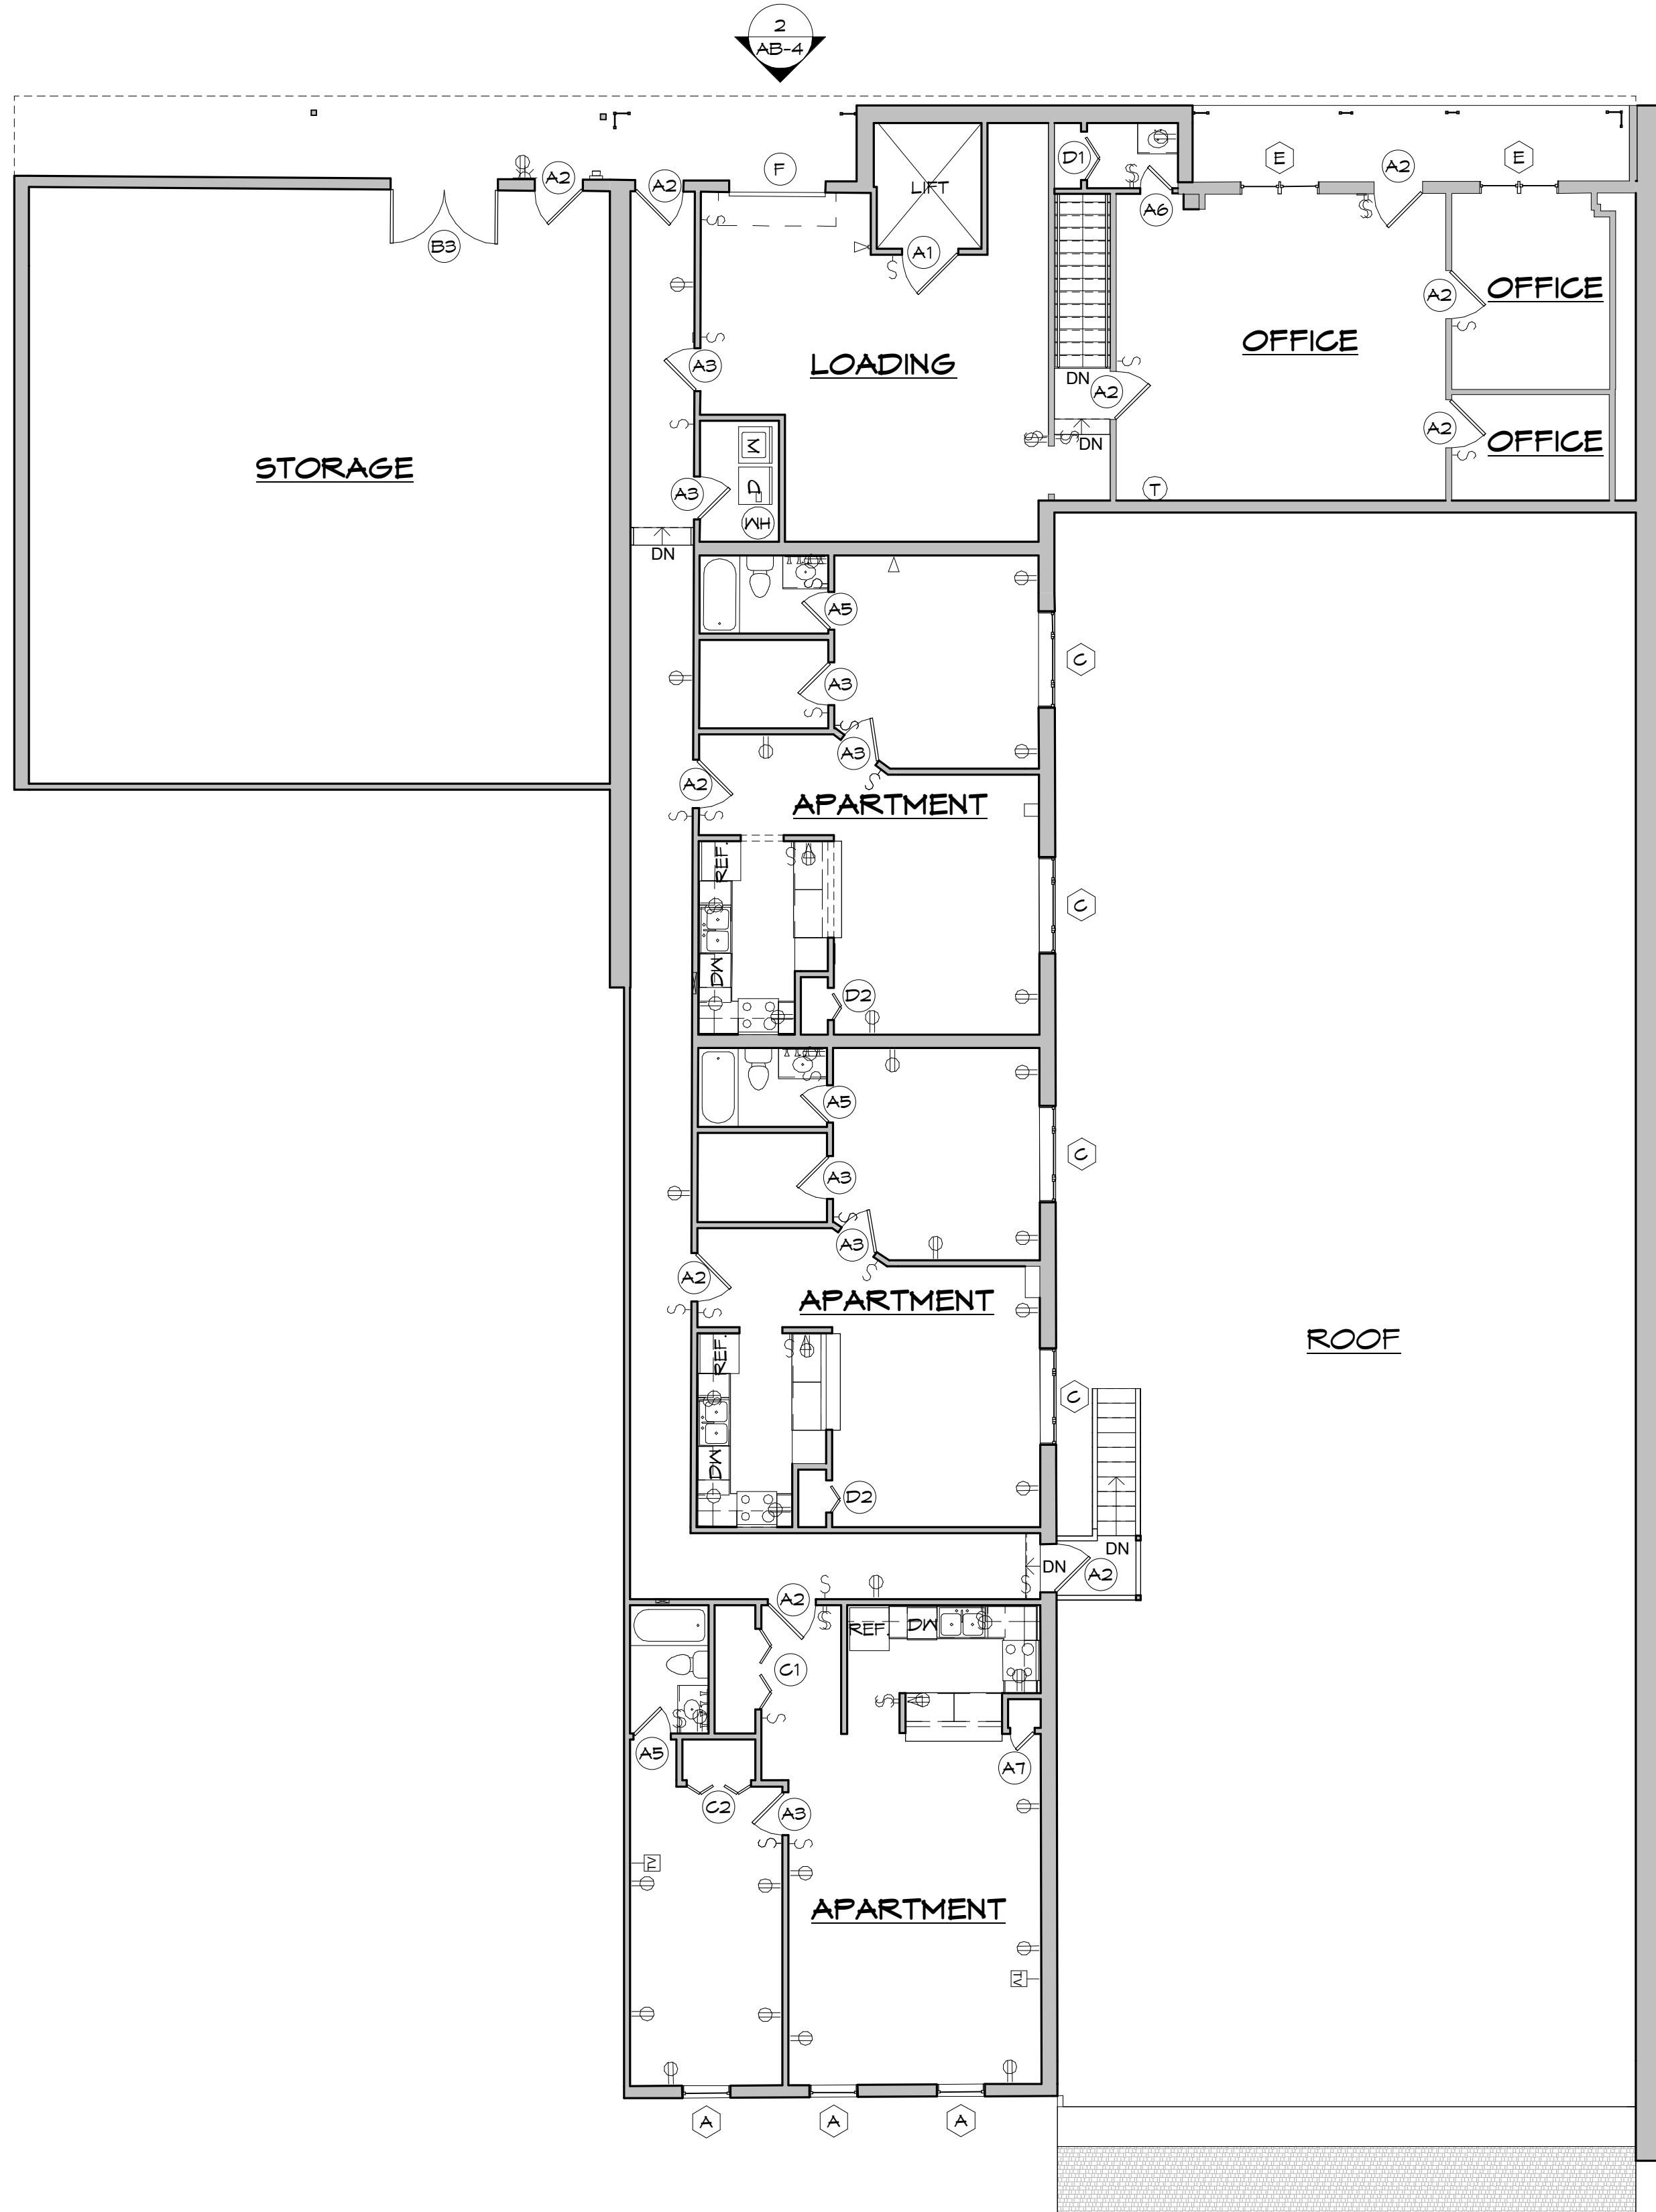

1 THIRD FLOOR
1/8" = 1'-0"

ARCHITECTURAL AS BUILT

Franklin, NC 28734

01	100% SUBMISSION	SEE COVER SHEET
NO.	ISSUES / REVISIONS	DATE

SHEET TITLE


THIRD FLOOR & RCP

Designer	PROJECT MANAGER
Designer	PROJECT DIRECTOR
Project Number	PROJECT NUMBER
Author	DRAWN BY
	SHEET NUMBER


AB-3




1 FRONT
1/8" = 1'-0"

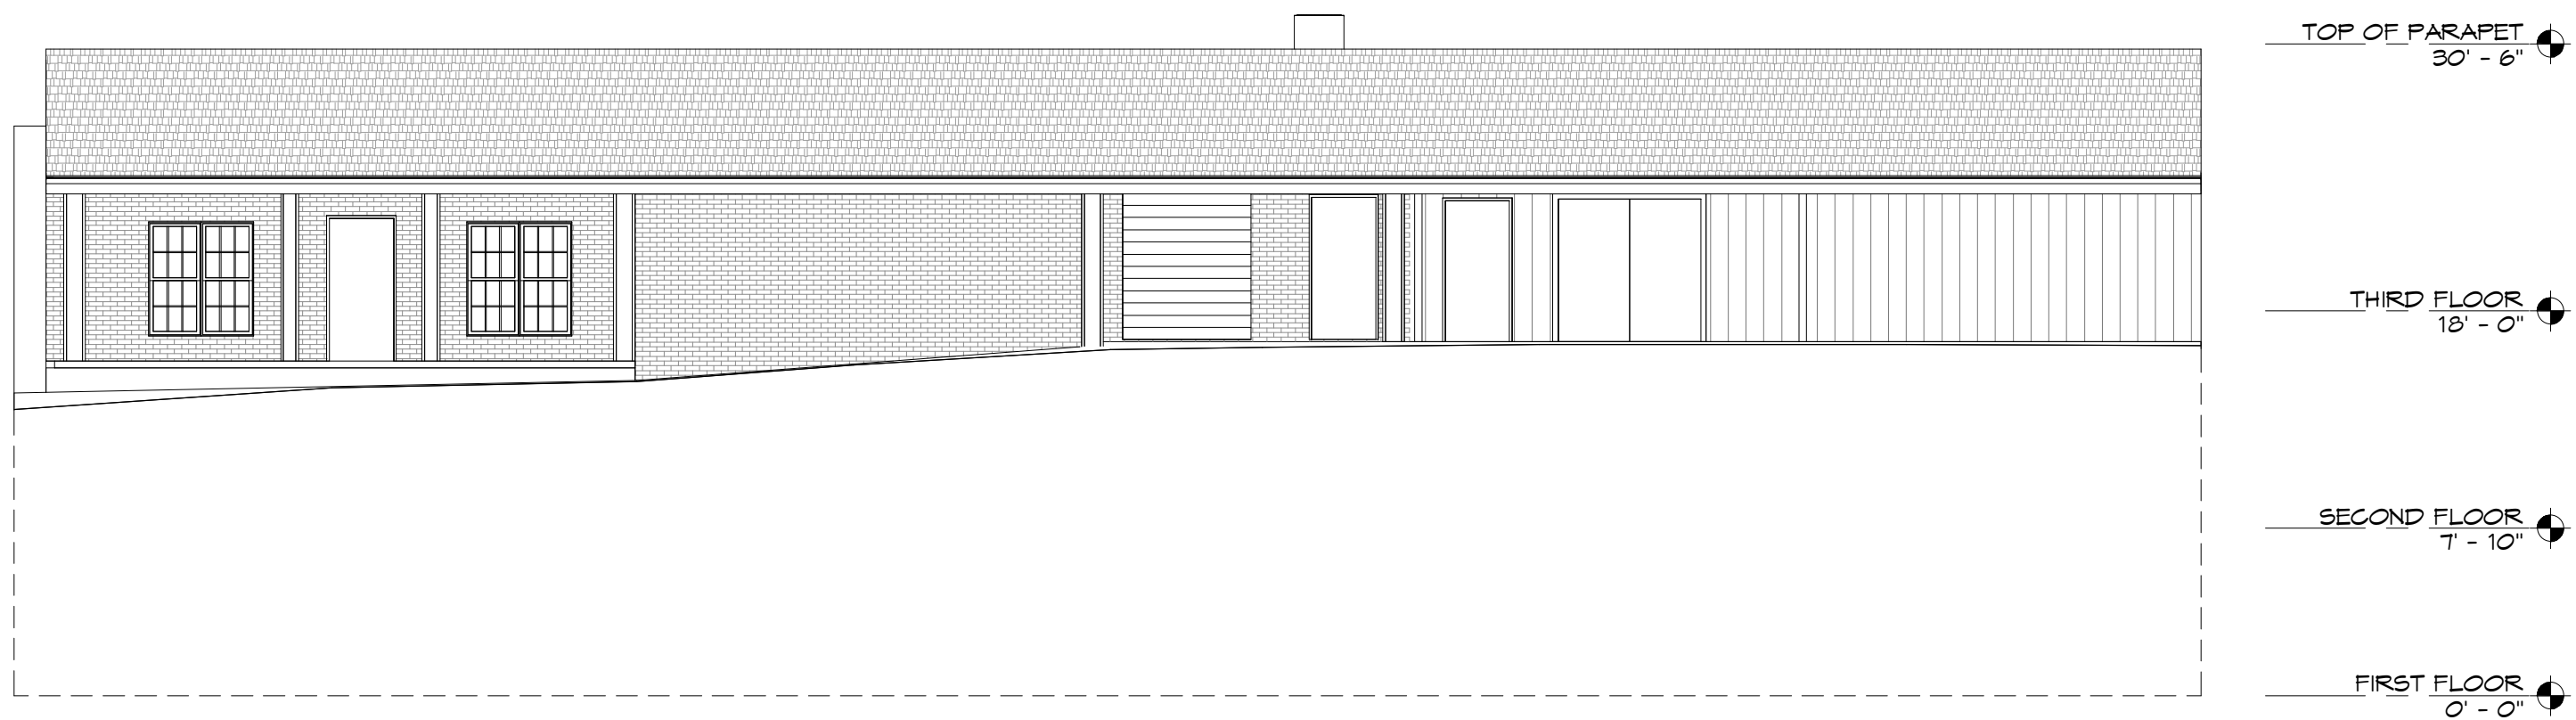

2 BACK
1/8" = 1'-0"

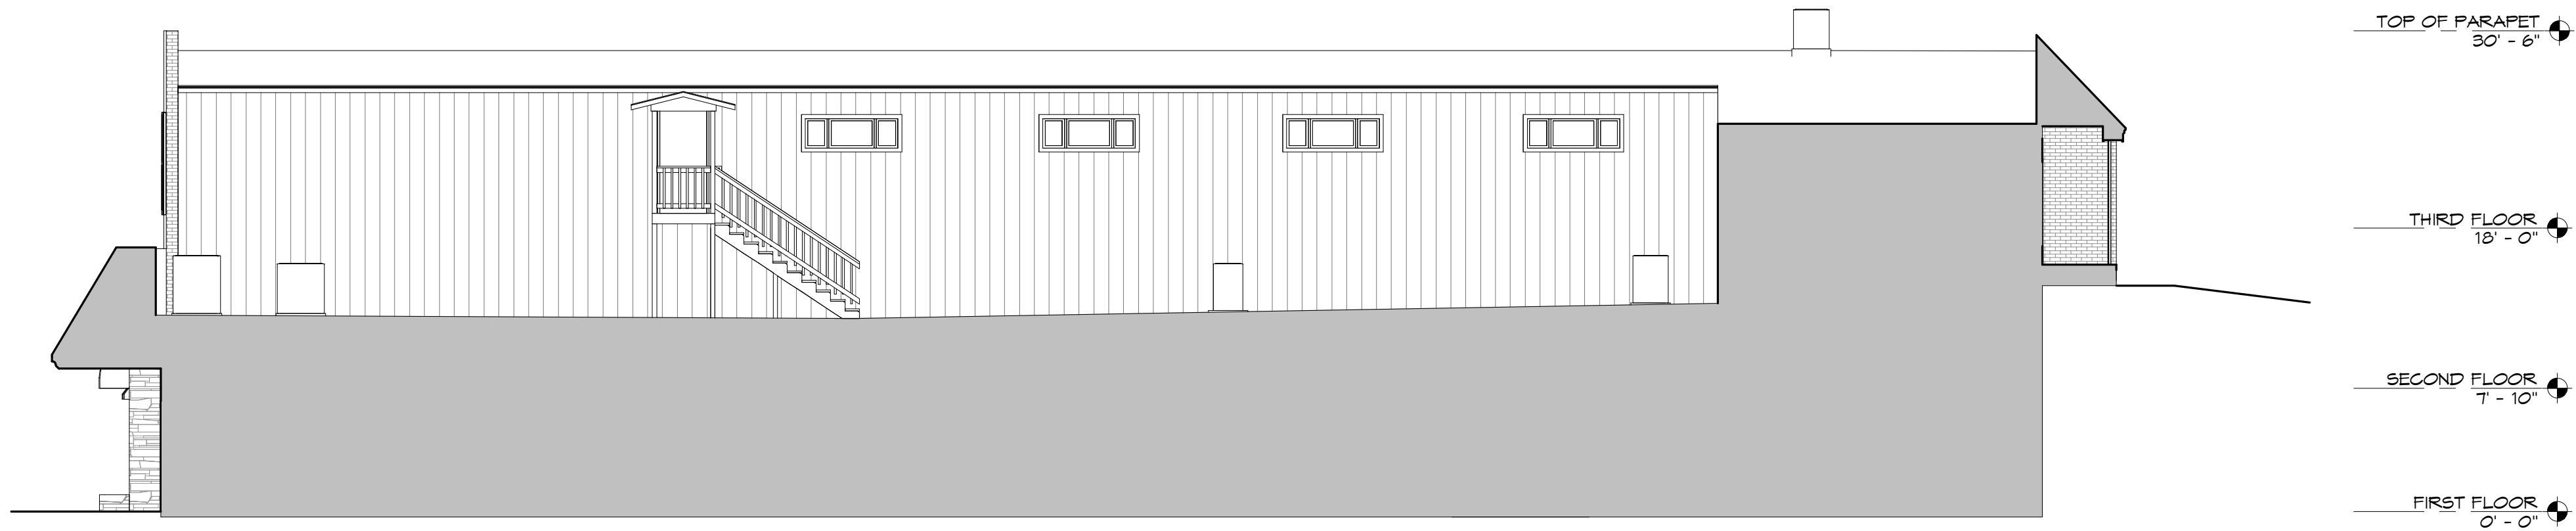

3 RIGHT
1/8" = 1'-0"

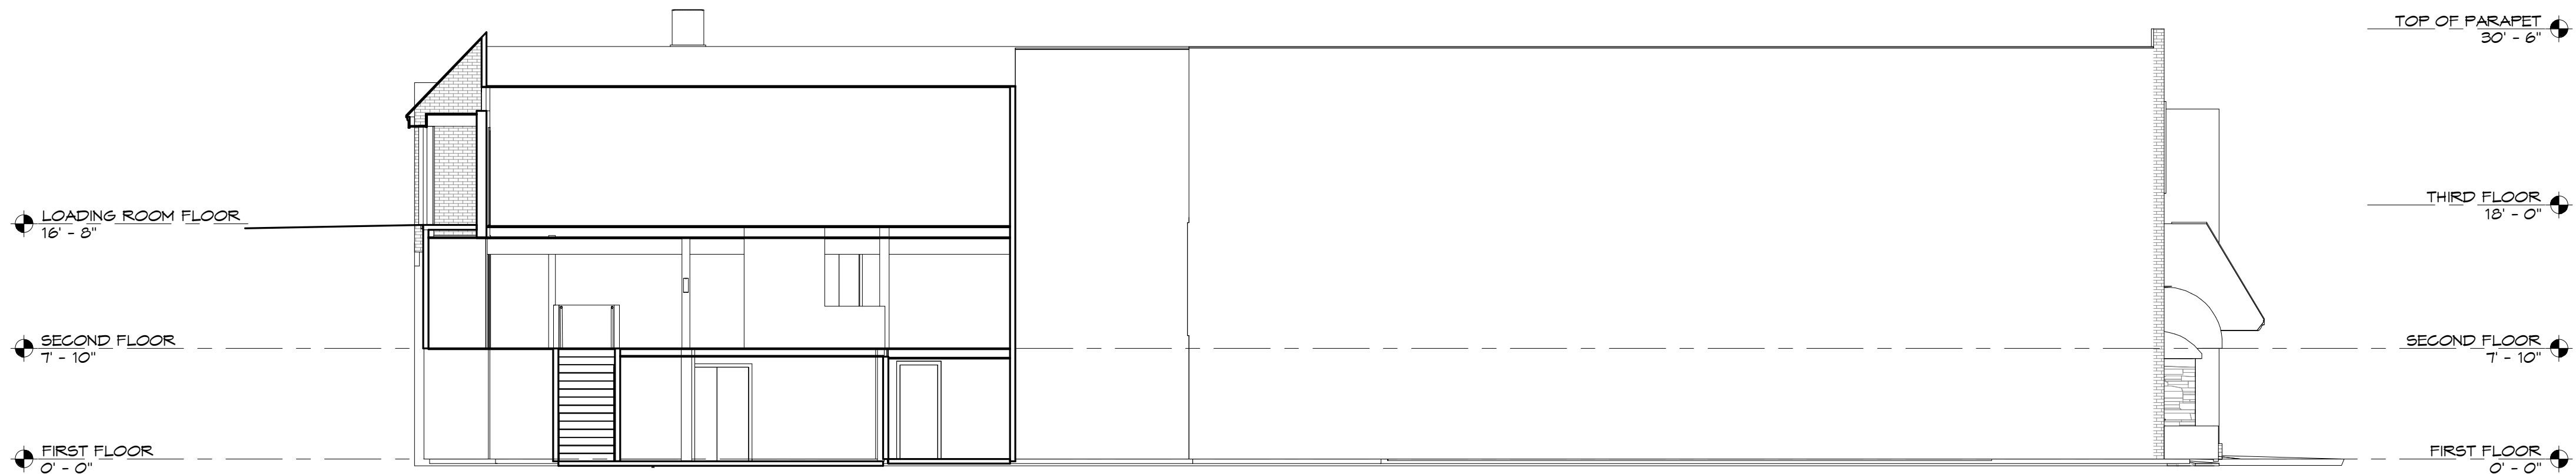




4 LEFT
1/8" = 1'-0"

AS BUILT
PROFESSIONALS
www.asbuiltprofessionals.com
A DIVISION OF:
AEC
CONSULTANTS INC
844.272.8458
844 A S B U I L T
© 2021 AEC CONSULTANTS INC

ARCHITECTURAL AS BUILT
Franklin, NC 28734

01	100% SUBMISSION	SEE COVER SHEET
NO.	ISSUES / REVISIONS	DATE
SHEET TITLE		

EXTERIOR ELEVATIONS	
Designer	PROJECT MANAGER
Designer	PROJECT DIRECTOR
Project Number	PROJECT NUMBER
	SCALE
Author	DRAWN BY
	SHEET NUMBER
AB-4	

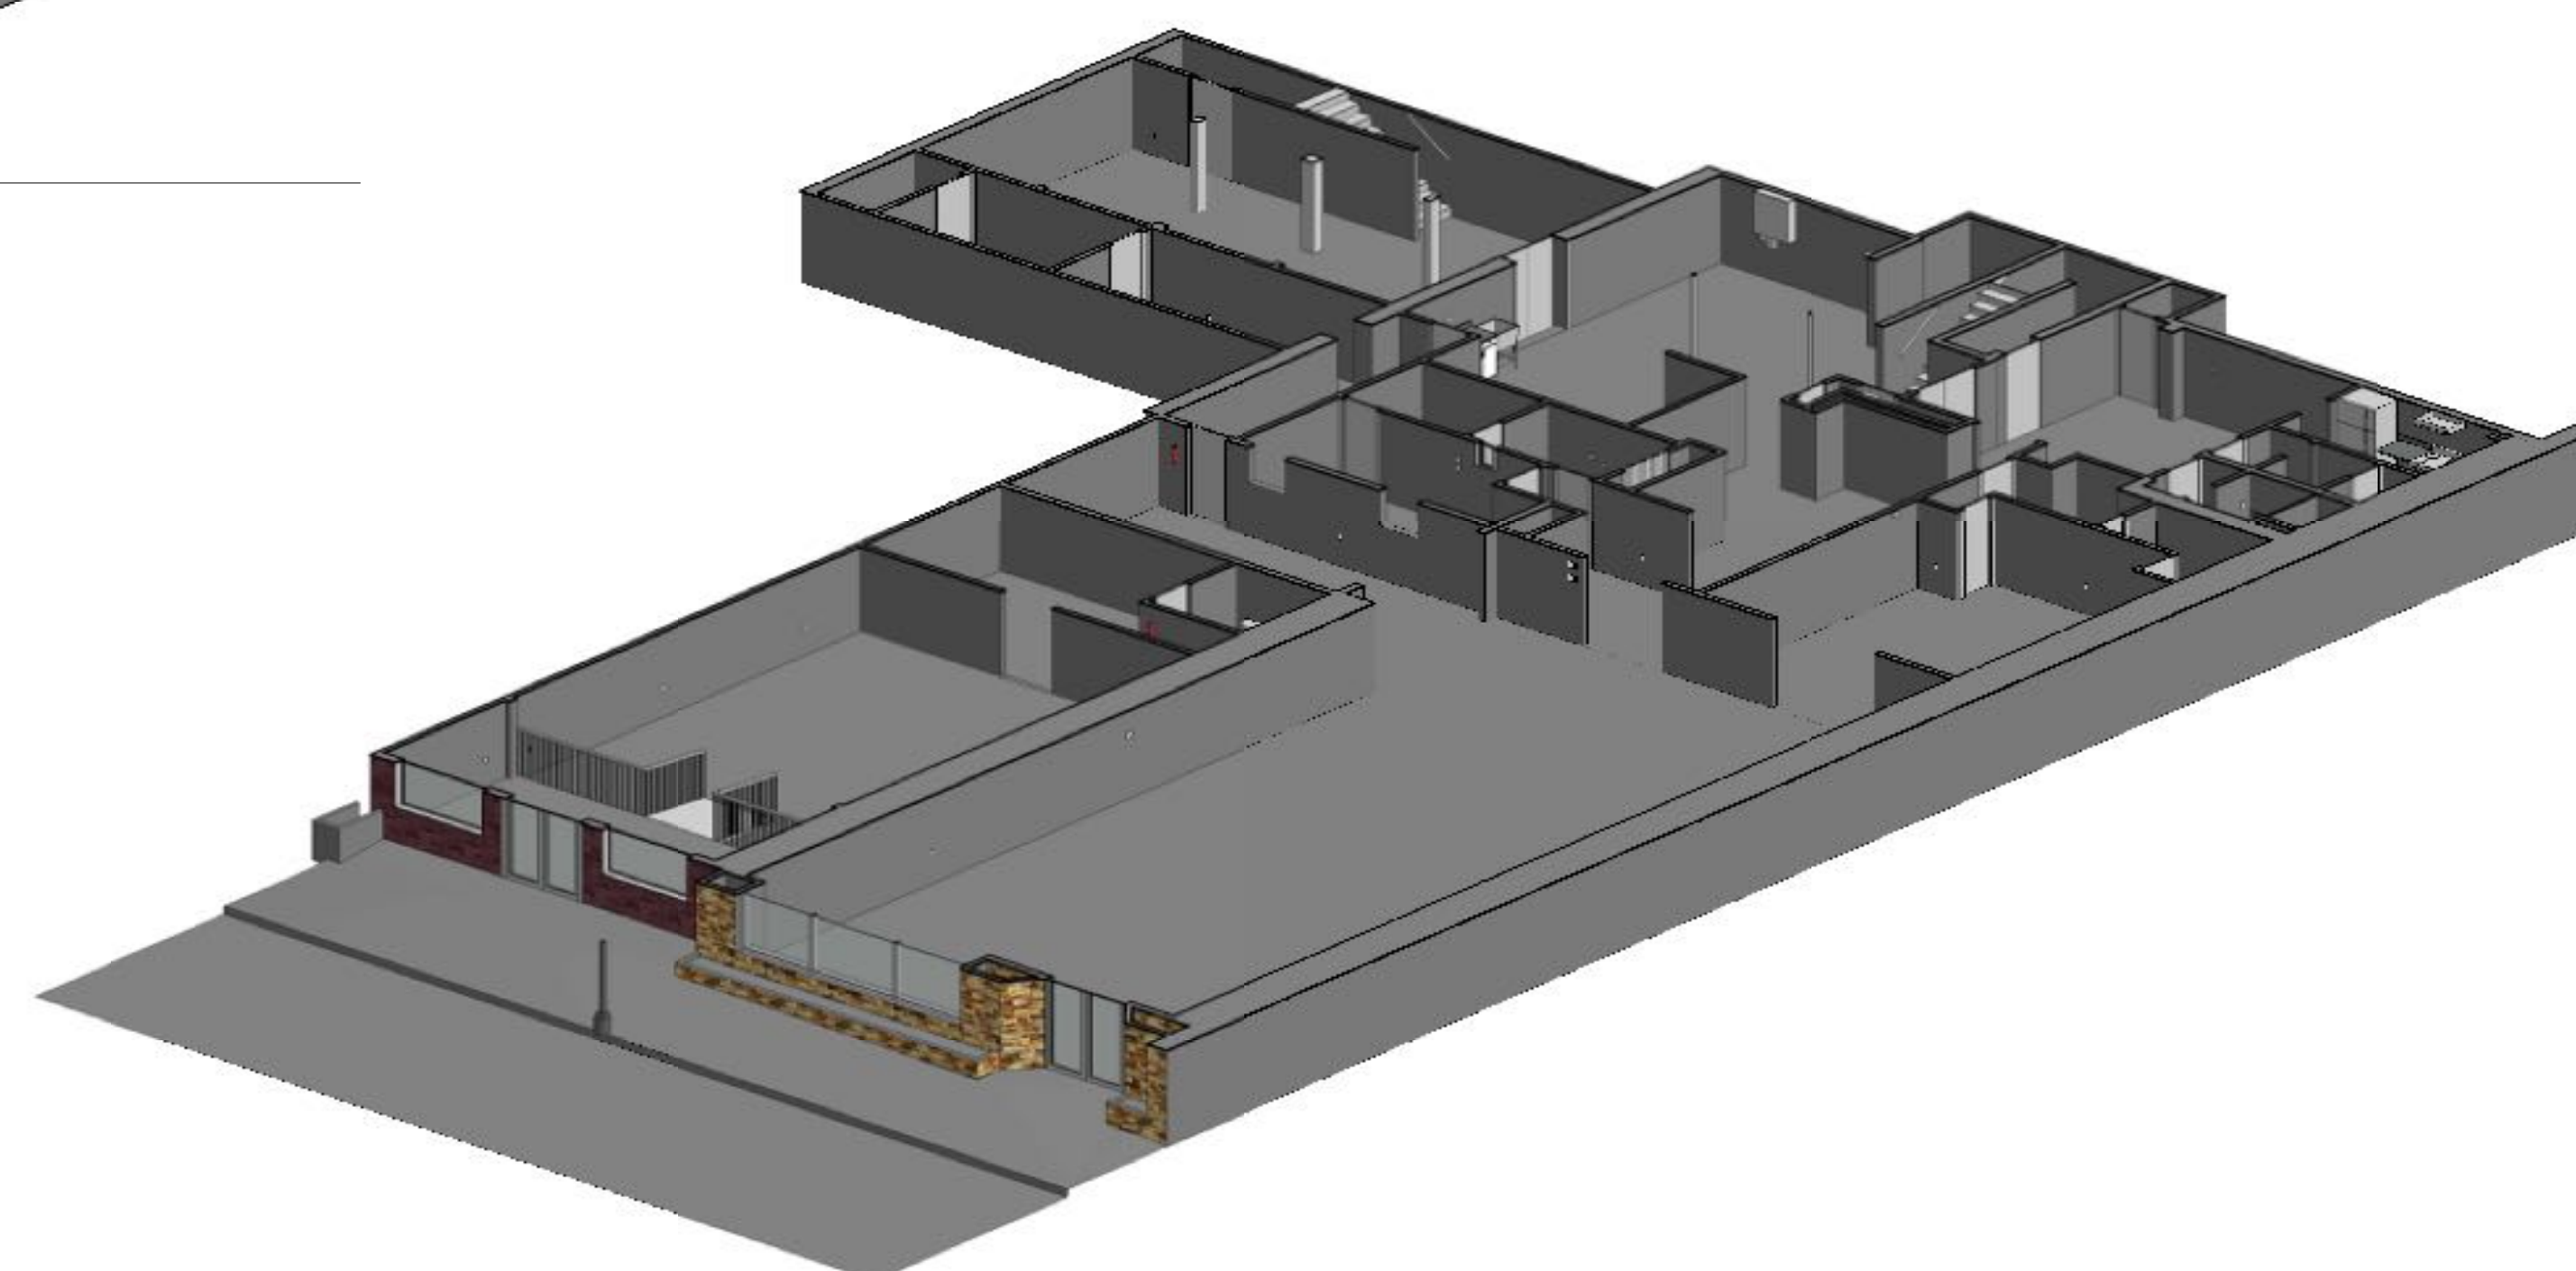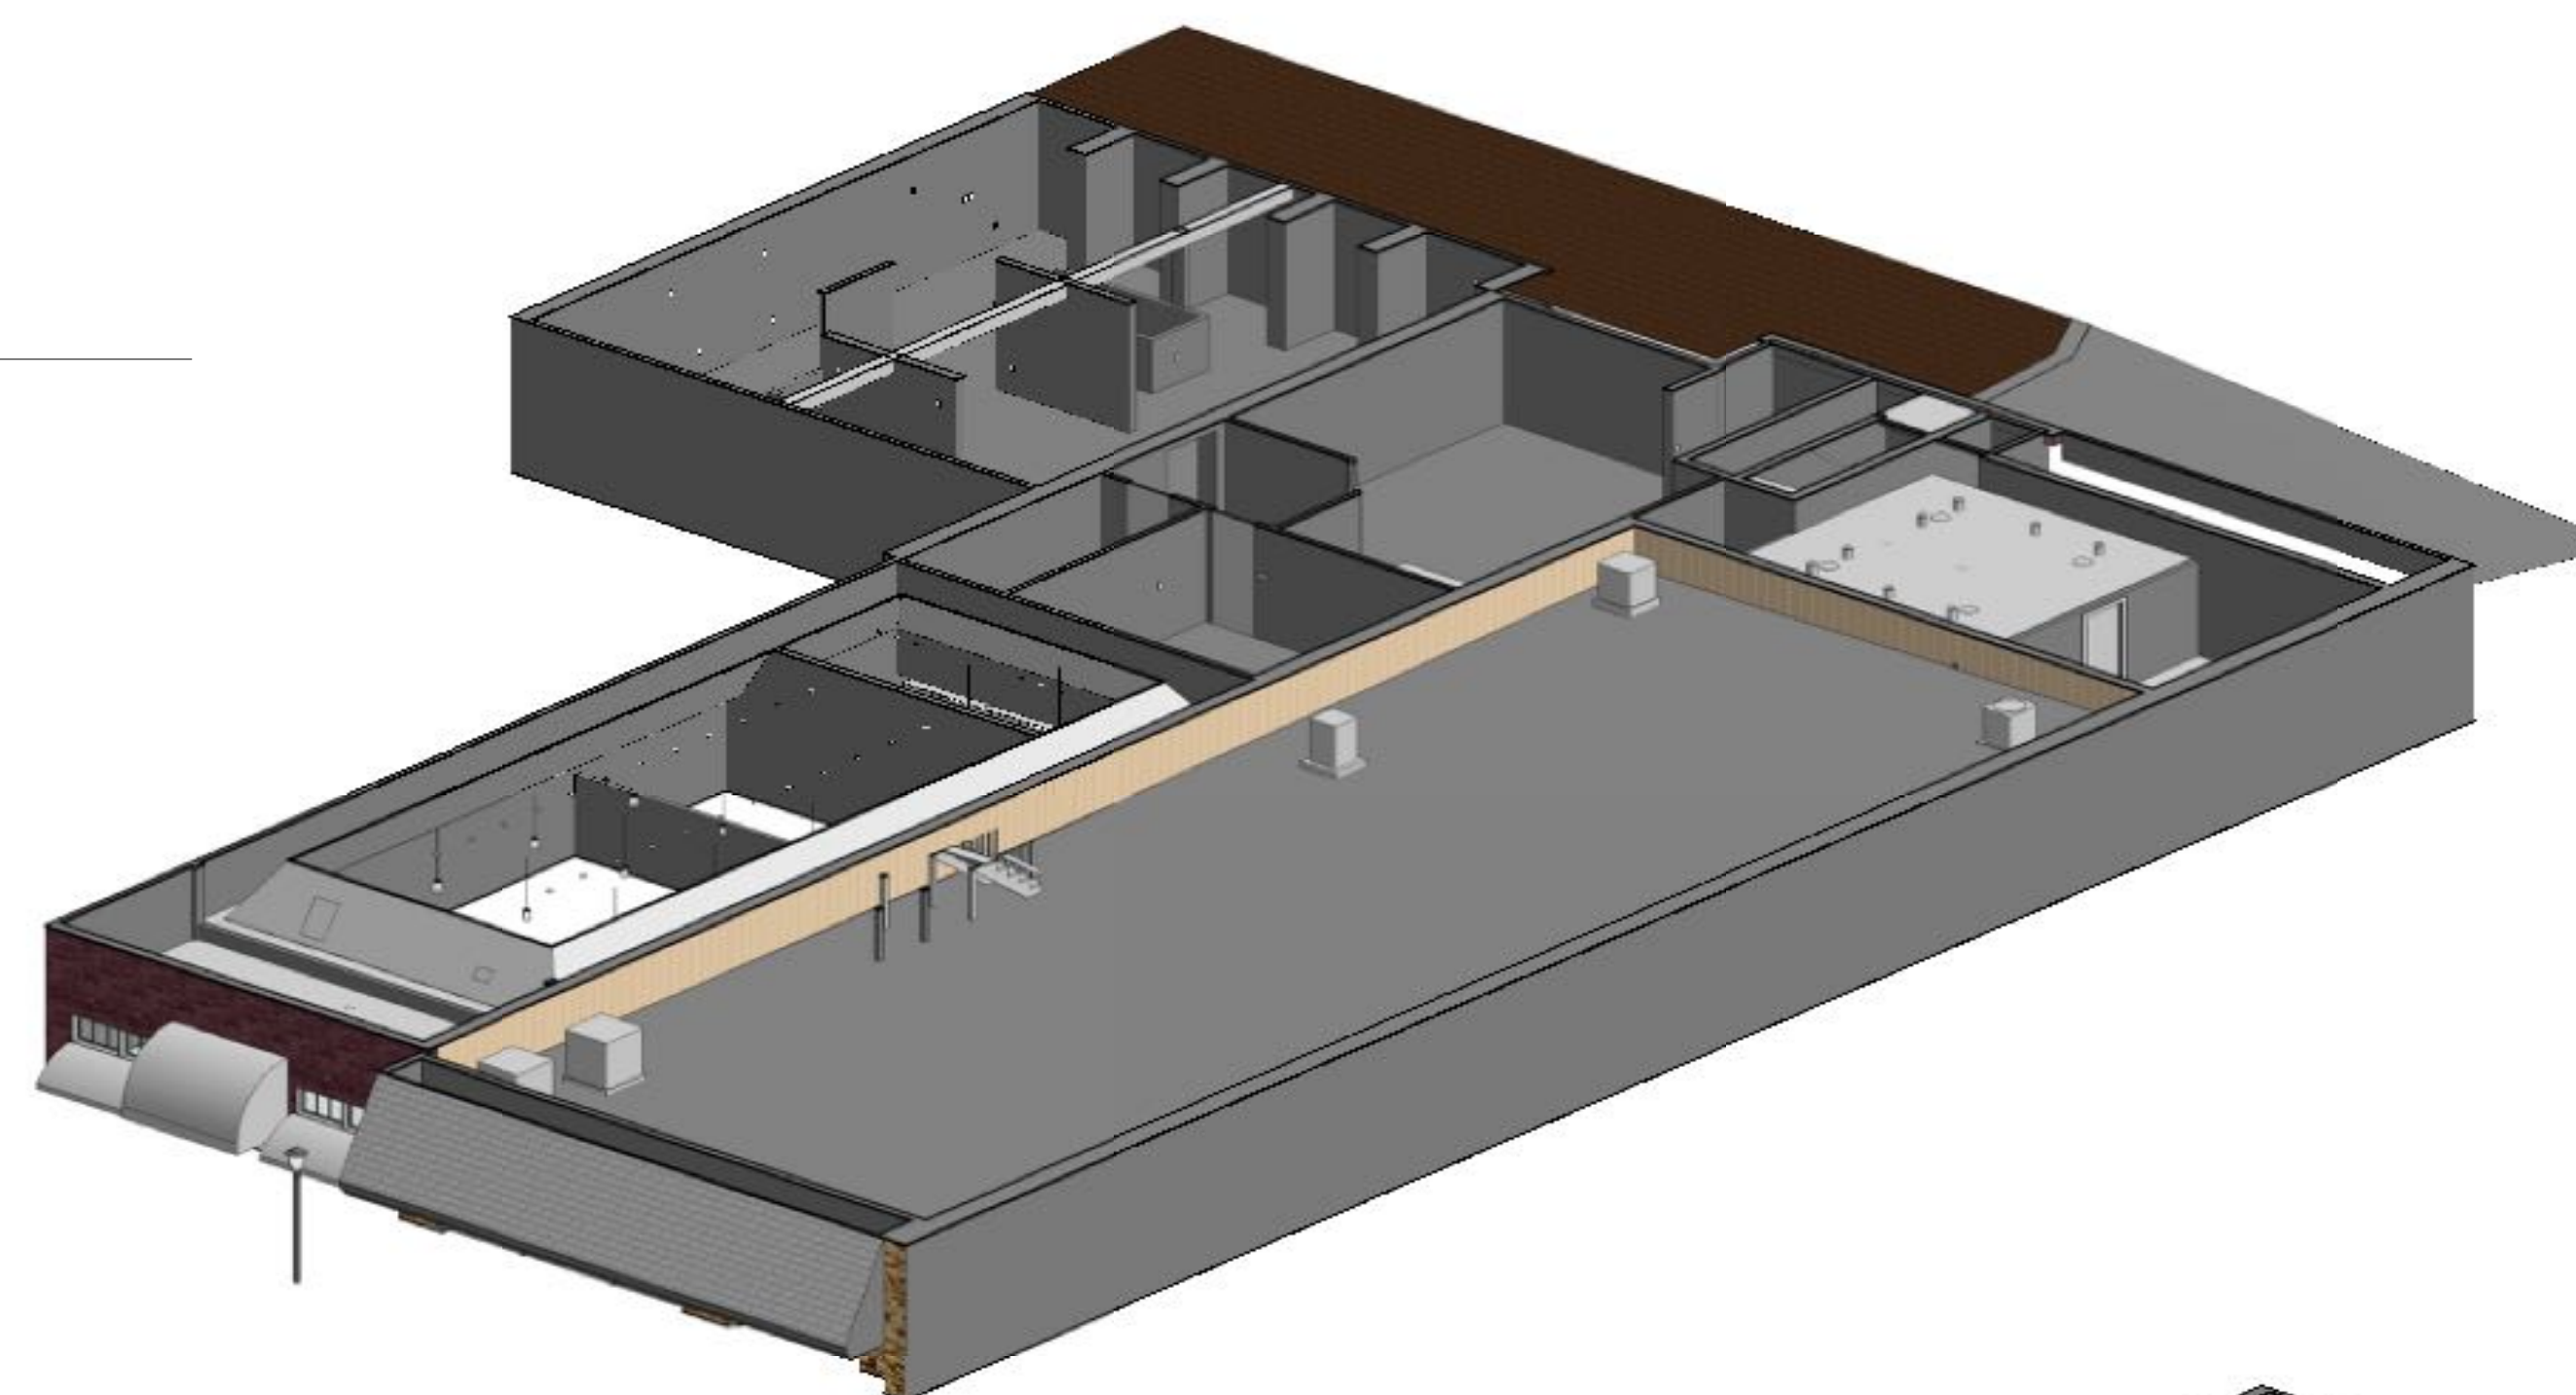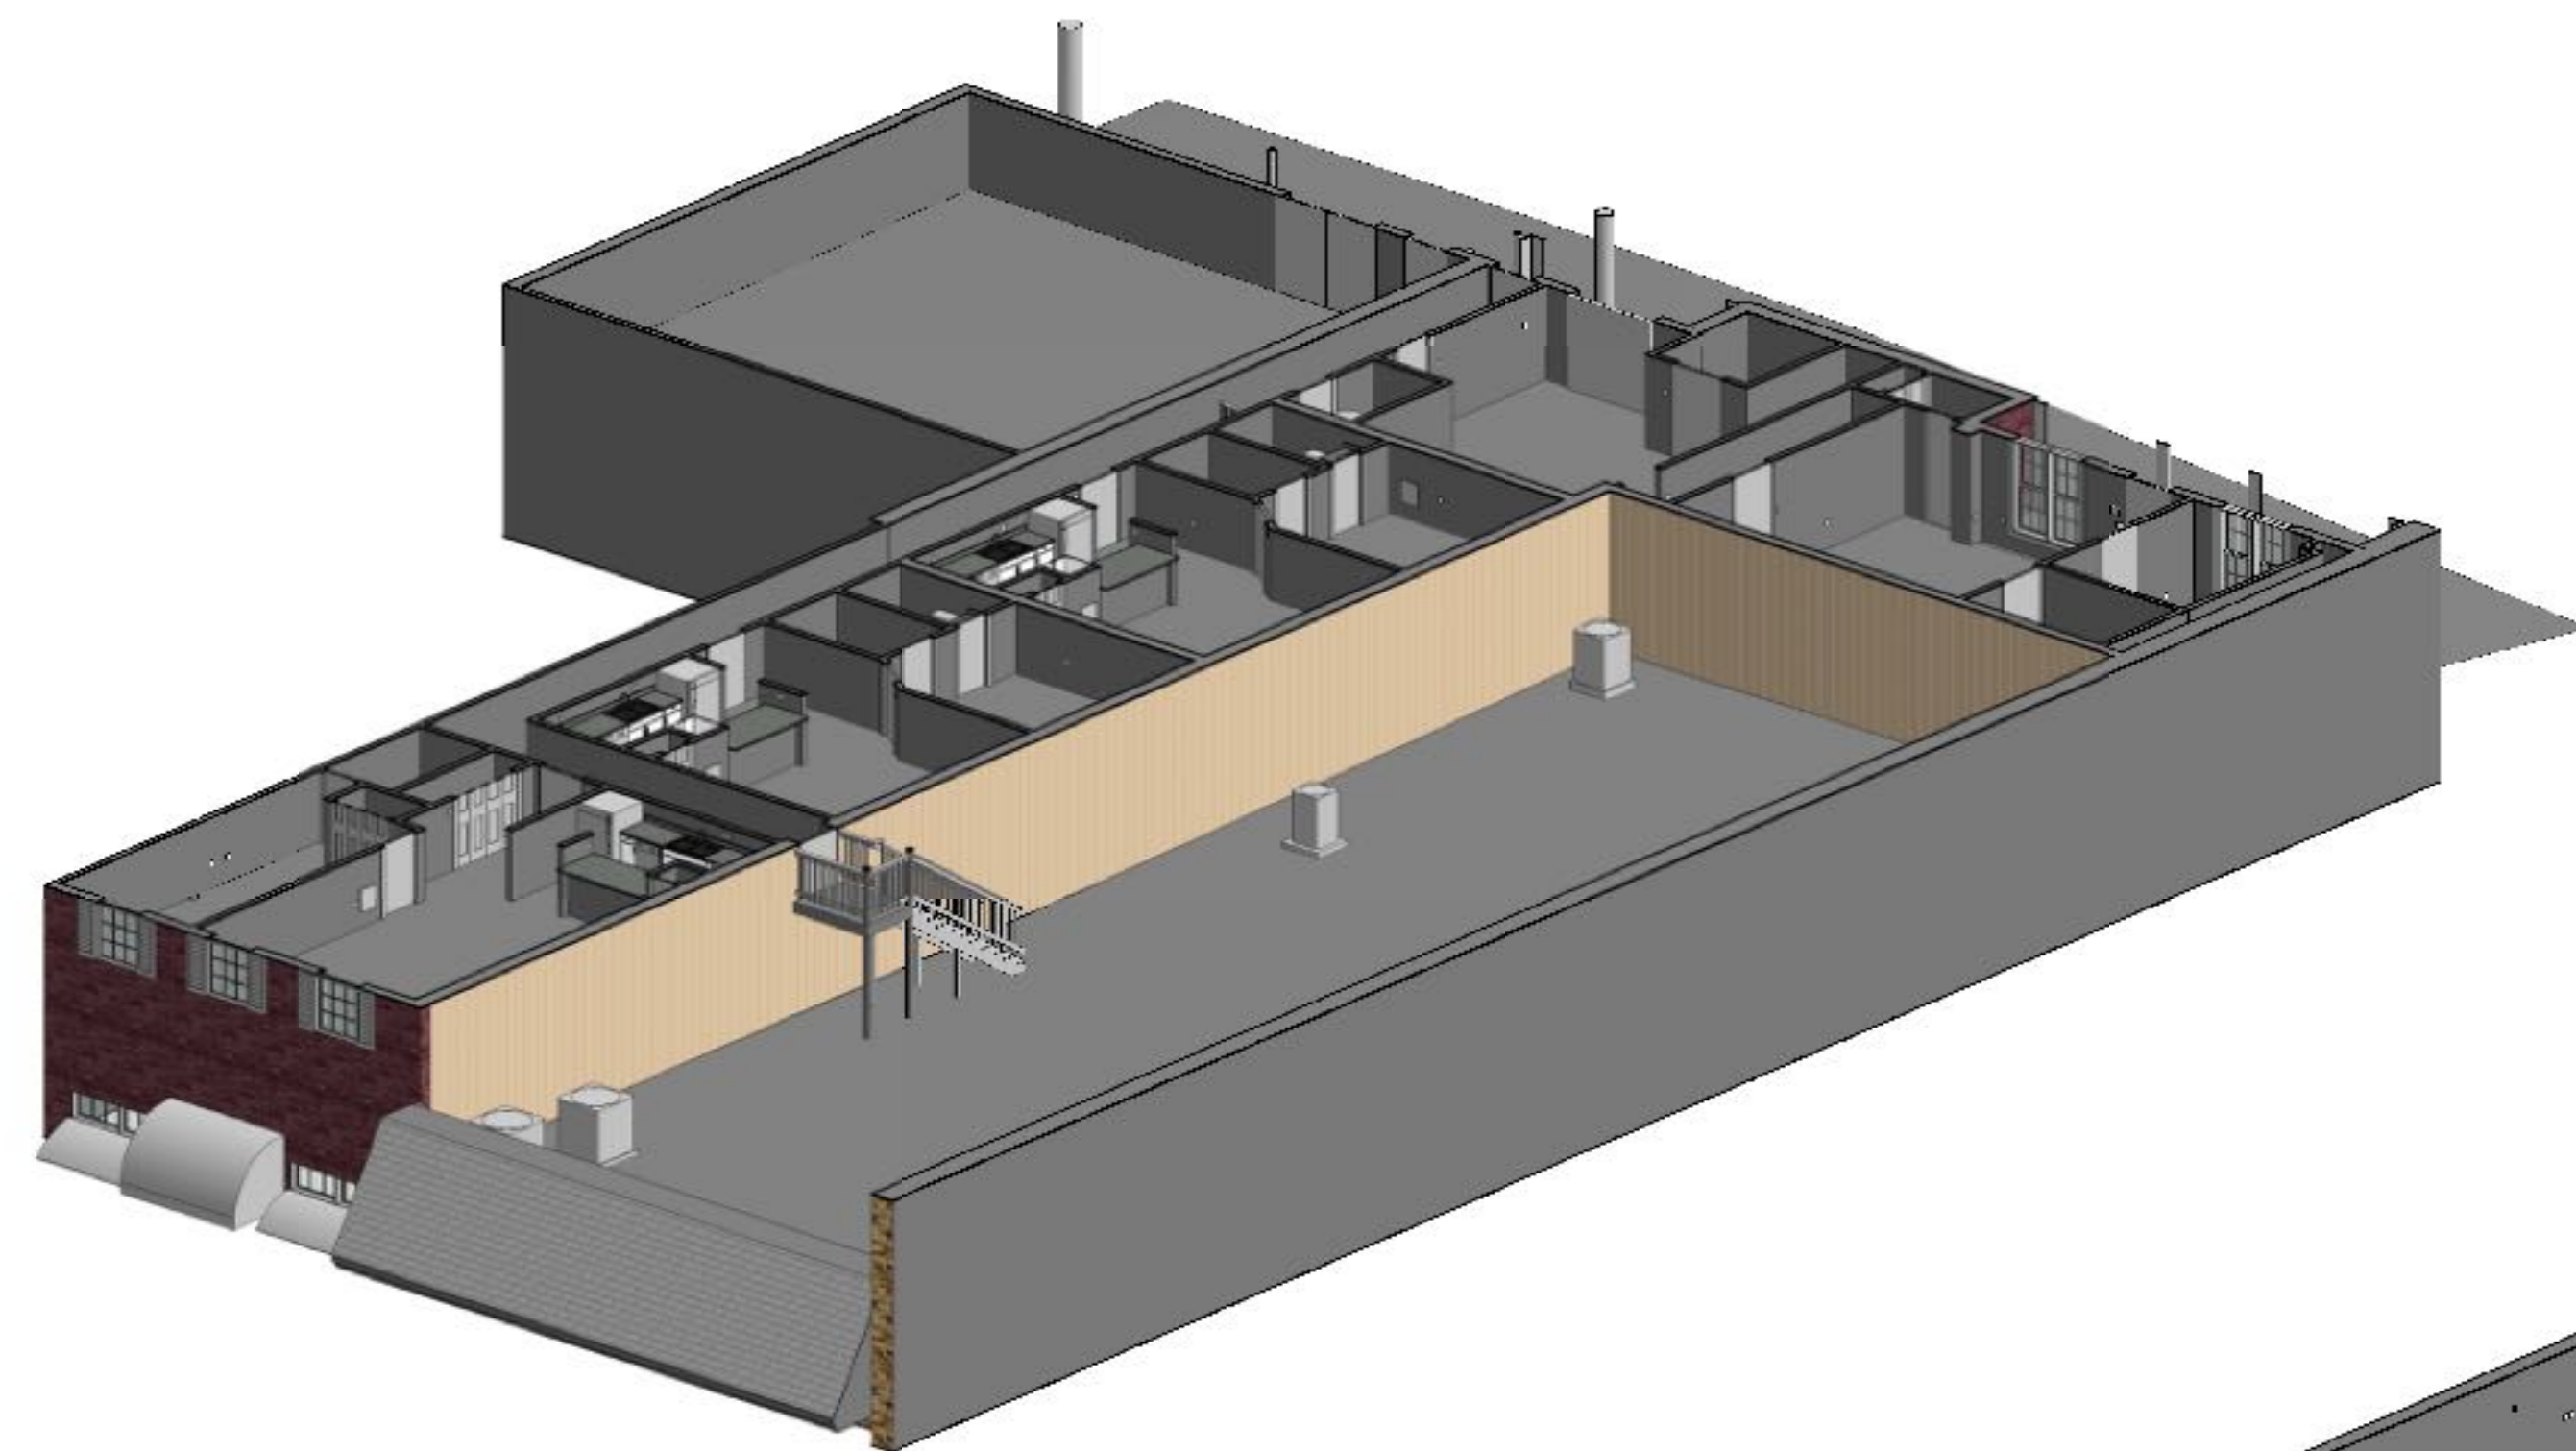

ARCHITECTURAL AS BUILT

Franklin, NC 28734

01.	100% SUBMISSION	SEE COVER SHEET
Nº:	ISSUES / REVISIONS	PAGE
		TOTAL PAGE

3D VIEWS

Designer	PROJECT MANAGER
Designer	PROJECT DIRECTOR
Project Number	PROJECT NUMBER
	SCALE
Author	DRAWN BY
	CHECK MANAGER

AB-5